

Gas bank : Not clarified about Gas Bank location/PNG pipeline

DG location : Terrace

Drain Points : Through basement in STP tank


North Direction : Marked On Outline

Duct/Shafts : To be provided by TFS

AC Outdoor locations : On Rear Wall/Terrace to be decided

Exhaust ODU : Terrace area

Location of FA & EX and AC ODUs will on side wall on MS Frame/Or on the terrace

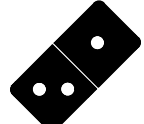

**Domino's Pizza**

JUBILANT FOODWORKS LTD.  
(DOMINO'S PIZZA INDIA LTD.)  
LOGIX TECHNO PARK, PLOT NO. 5,  
TOWER - D, 5th FLOOR,  
SECTOR - 127, NOIDA-201304.  
PHONE: 0120-4090500, 4090594.

THESE PLANS & SPECIFICATIONS AS WELL AS DOMINO'S NAME & LOGO, TRADEMARKS & DESIGNS ARE THE EXCLUSIVE PROPERTY OF JUBILANT COMPANY. ANY REPRODUCTION, MODIFICATION, DISCLOSURE AND/OR USE OF THESE MATERIALS (OR BY PORTION OF THEM) WITHOUT DOMINO'S PRIOR WRITTEN CONSENT IS STRICTLY PROHIBITED.

**DISCLAIMER-**  
IN CASE OF ANY SITE DISCREPANCY, PLEASE GET BACK TO CORPORATE DESIGN TEAM

JUBILANT FOODWORKS INDIA LTD.

PROJ : UNA. HIMACHAL  
ZONE : PREDESH  
COUNTRY : NORTH INDIA.


RESTAURANT NO. : .


TOTAL CARPET AREA : 631 SQ.FT.  
CUSTOMER AREA : SQ.FT.  
KITCHEN AREA : 405 SQ.FT.  
BOH AREA : 236 SQ.FT.  
NO. OF COVERS :  
BOTTOM OF SLAB : 3734  
BOTTOM OF BEAM : 3110 & 3445  
SHUTTER OPENING HT. : ----

DRAWN BY : VARUN	
CHECKED BY :	
ISSUED ON : 22-01-2024	
REVISION NO.	REVISION DATE
1	-2022
2	-2022
3	-2022
4	-2022

REMARKS :  
SCALE : NOT TO SCALE.  
SHEET NO. : 1  
SHEET TITLE : PLAN

NOTE: ALL THE DOOR AND FURNITURE TO BE FINISHED IN LOUISIANA OAK 5082 GREENLAM

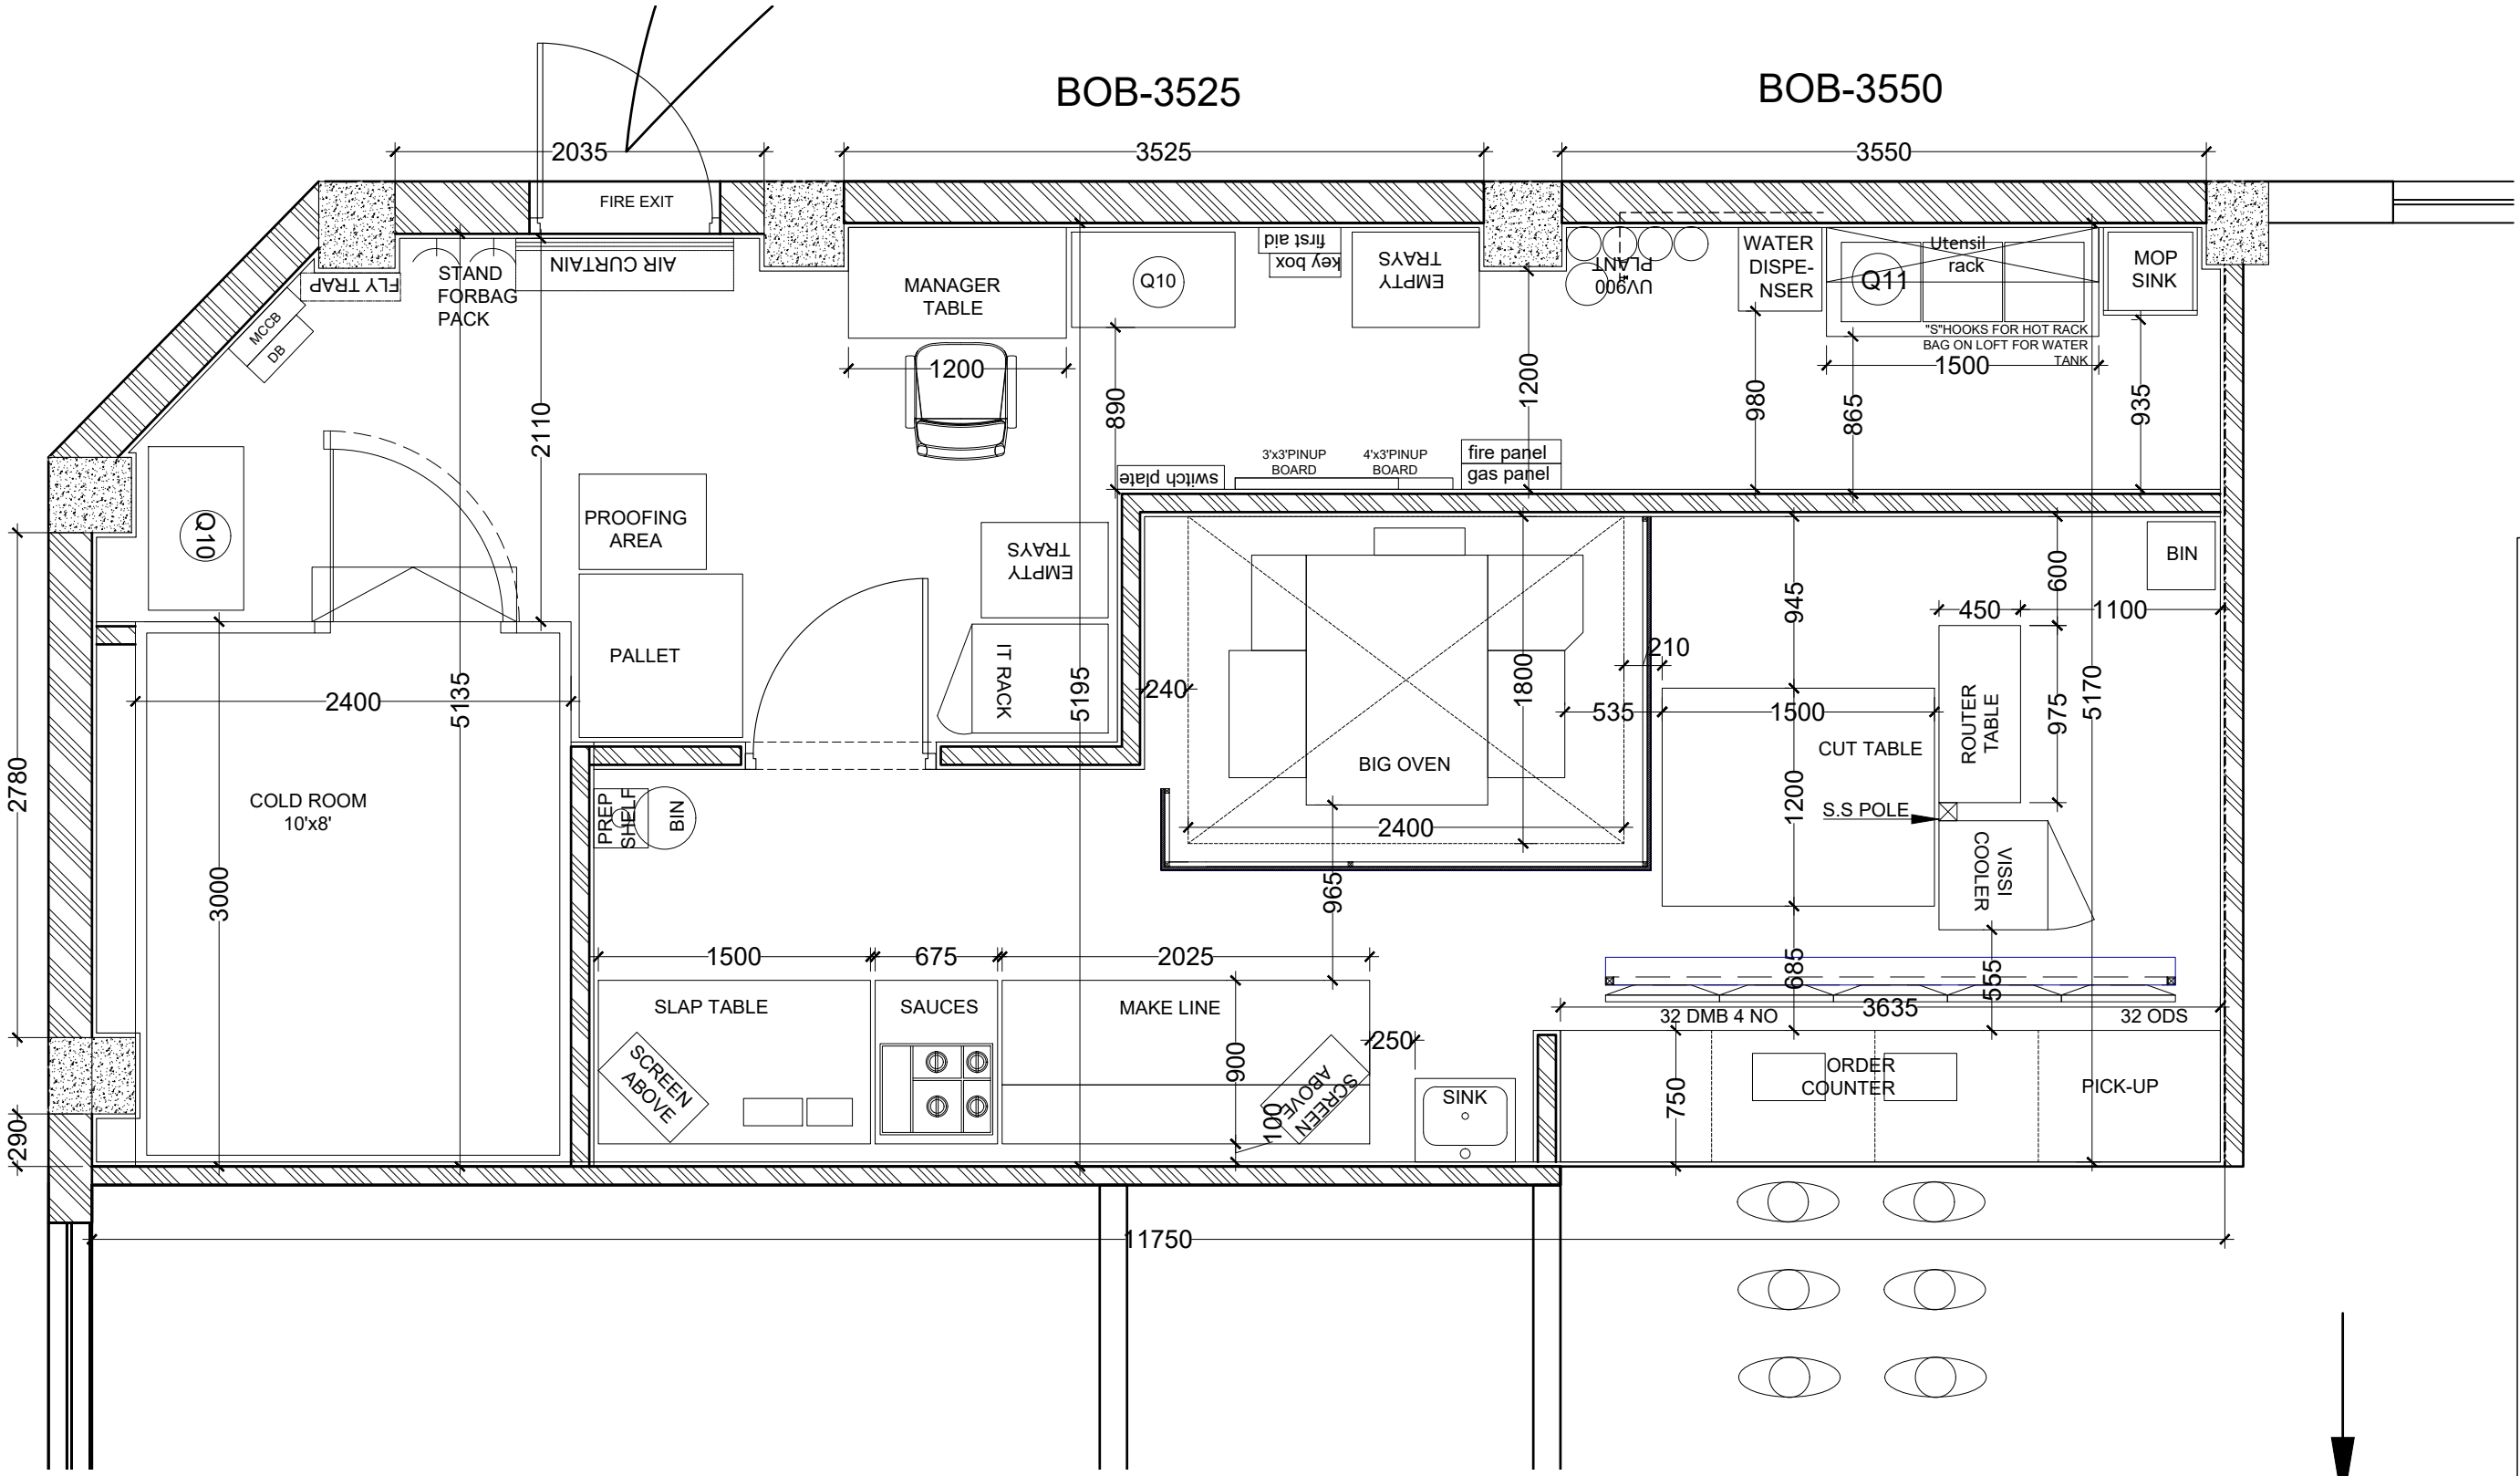

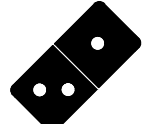

**Domino's  
Pizza**

JUBILANT FOODWORKS LTD.  
(DOMINO'S PIZZA INDIA LTD.)  
LOGIX TECHNO PARK, PLOT NO. 5,  
TOWER - D, 5th FLOOR,  
SECTOR - 127, NOIDA-201304.  
PHONE: 0120-4090500, 4090594.

THESE PLANS & SPECIFICATIONS AS WELL AS DOMINO'S NAME & LOGO, TRADEMARKS & DESIGNS ARE THE EXCLUSIVE PROPERTY OF JUBILANT COMPANY. ANY REPRODUCTION, MODIFICATION, DISCLOSURE AND/OR USE OF THESE MATERIALS (OR BY PORTION OF THEM) WITHOUT DOMINO'S PRIOR WRITTEN CONSENT IS STRICTLY PROHIBITED.

**DISCLAIMER-**  
IN CASE OF ANY SITE DISCREPANCY,  
PLEASE GET BACK TO CORPORATE  
DESIGN TEAM

JUBILANT FOODWORKS  
INDIA LTD.

PROJ :UNA. HIMACHAL  
ZONE :PREDESH  
COUNTRY :INDIA.


RESTAURANT NO.: .

TOTAL CARPET AREA : 631 SQ.FT.  
CUSTOMER AREA : SQ.FT.  
KITCHEN AREA : 405 SQ.FT.  
BOH AREA : 236 SQ.FT.  
NO. OF COVERS :  
BOTTOM OF SLAB : 3734  
BOTTOM OF BEAM : 3110 & 3445  
SHUTTER OPENING HT.:----


DRAWN BY : VARUN  
CHECKED BY :  
ISSUED ON : 22-01-2024

REVISION NO.	REVISION DATE
1	-2022
2	-2022
3	-2022
4	-2022

REMARKS :  
SCALE : NOT TO SCALE.  
SHEET NO. : 2  
SHEET TITLE : EQUIPMENT PLAN

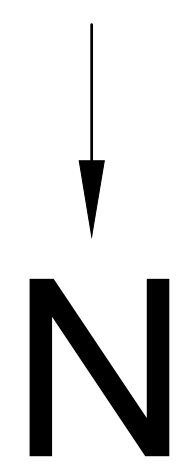

SYMBOL	PRODUCT- DESCRIPTION	
D-1	BOH EXIT DOOR	(DOOR FINISH WITH - LOUISIANA OAK 5082 GREENLAM)
D-2	BOH ENTRY DOOR	(DOOR FINISH WITH - LOUISIANA OAK 5082 GREENLAM)

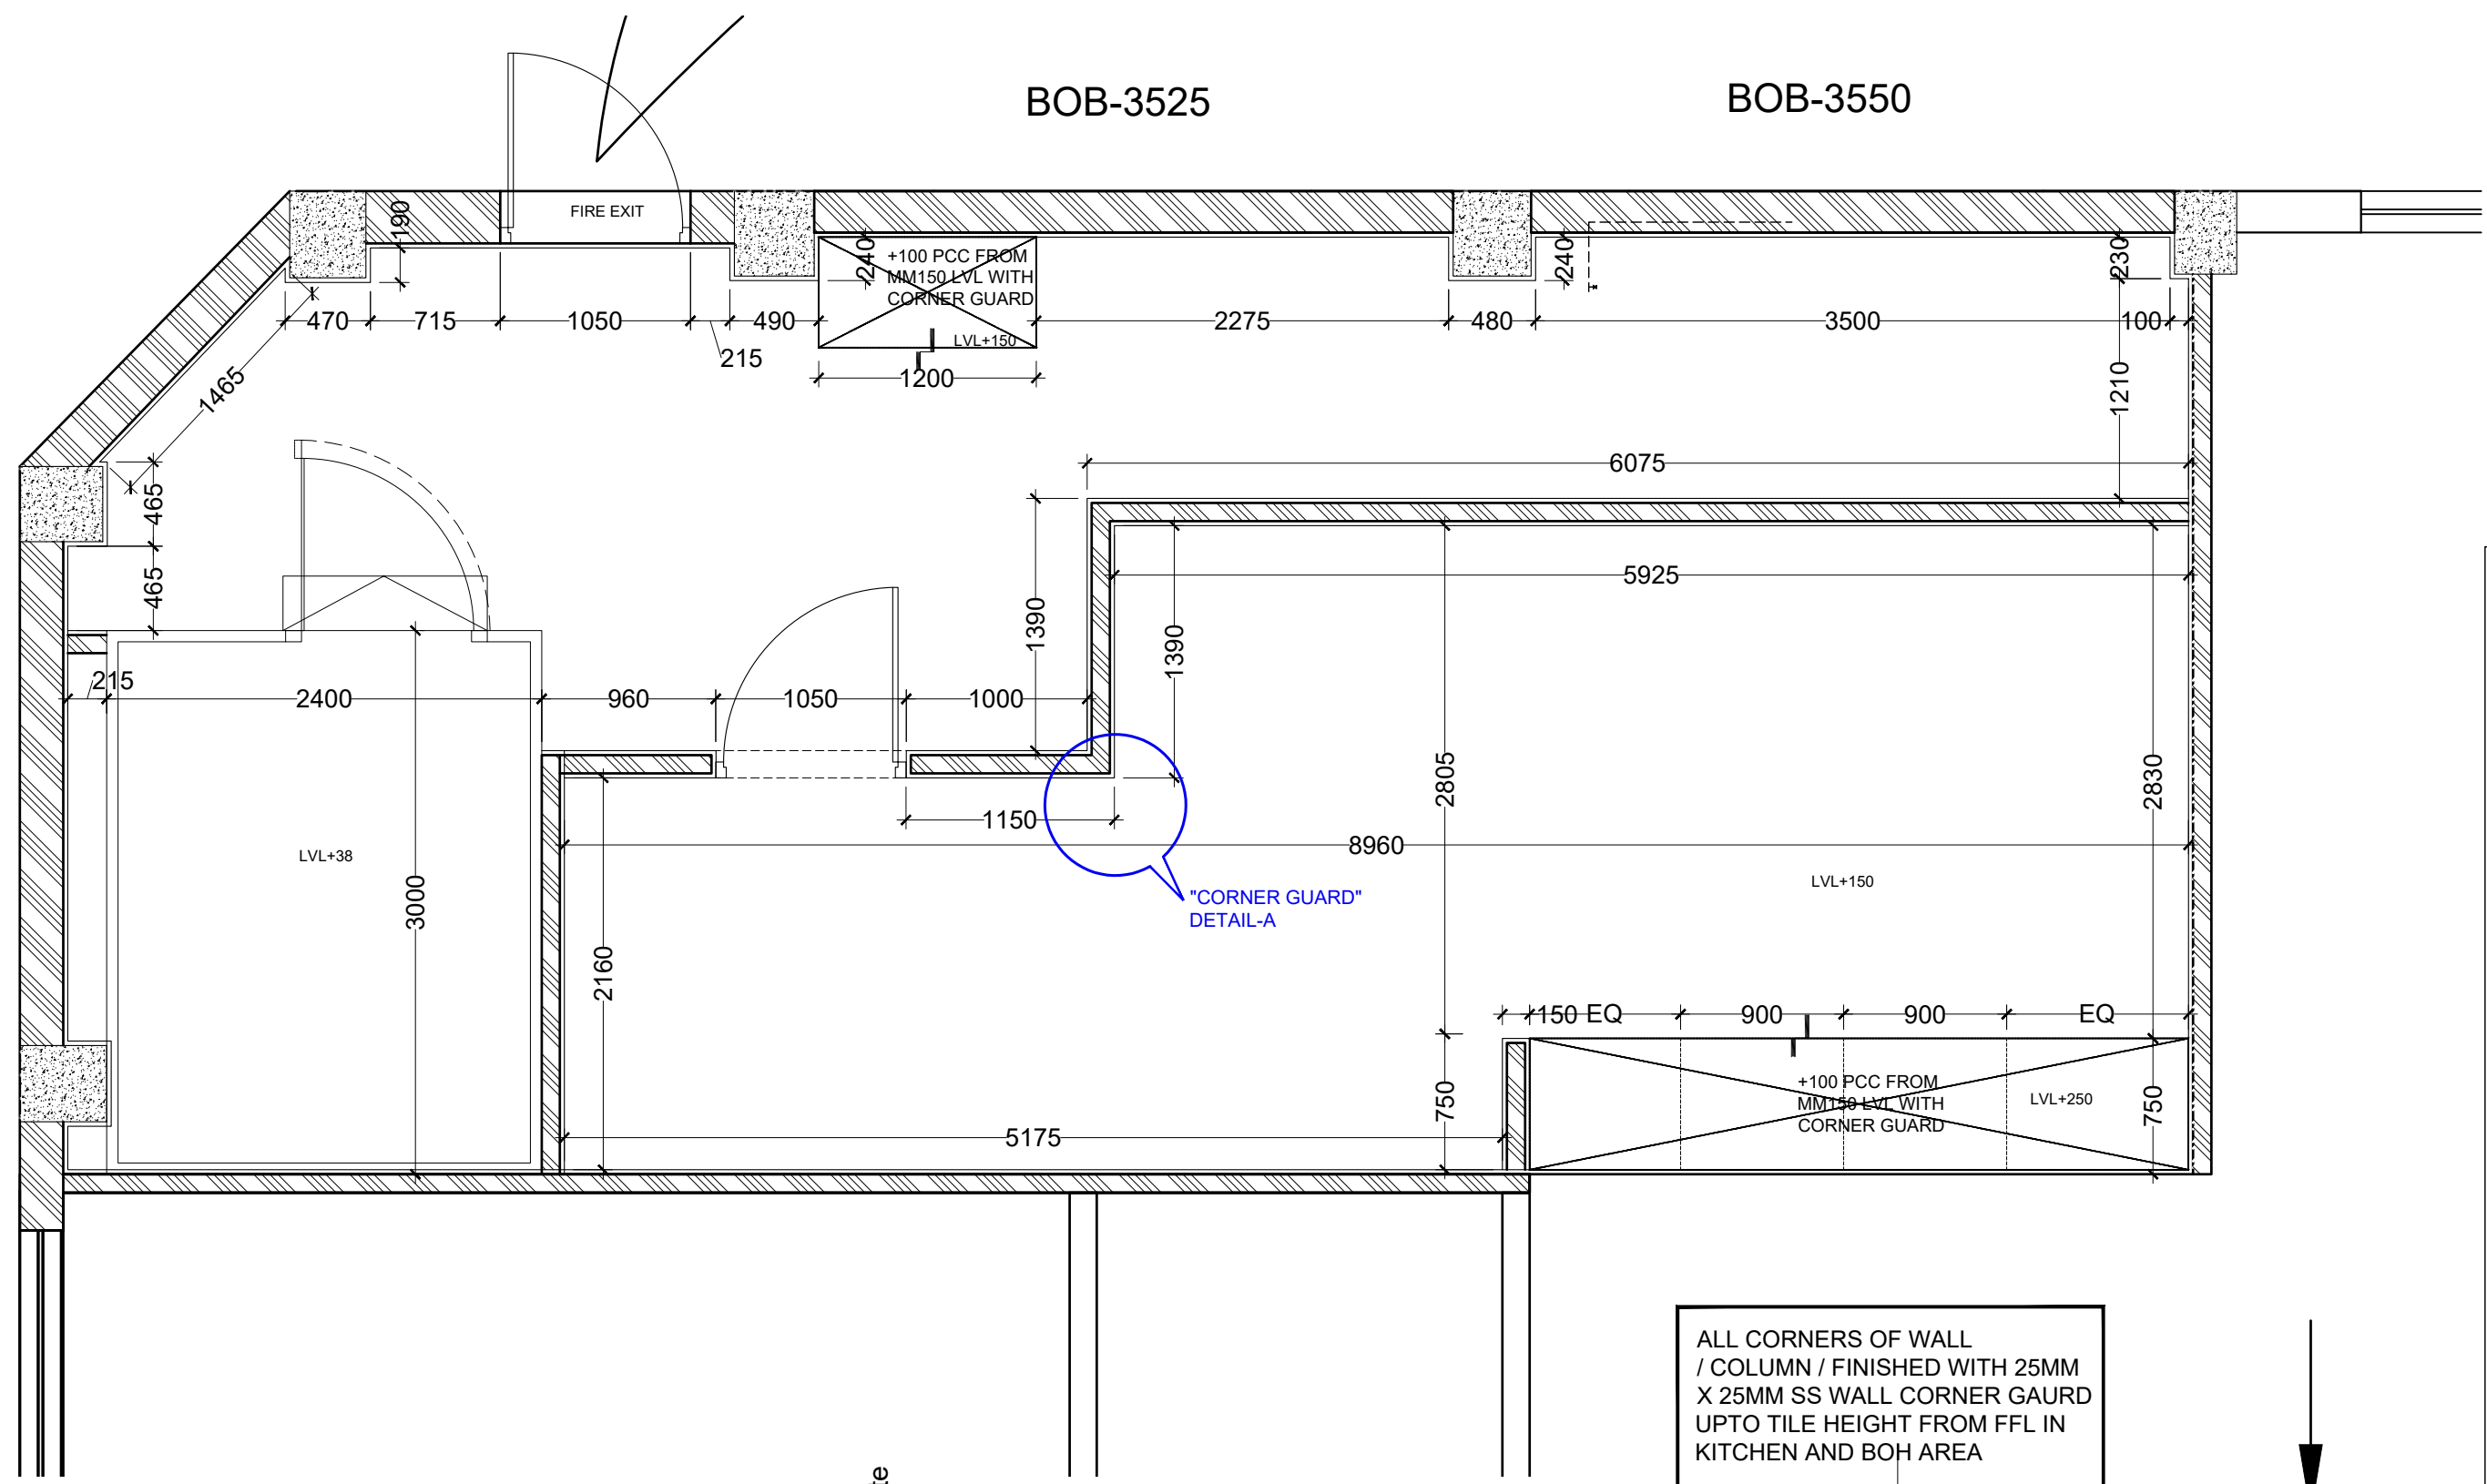

BOB-3525

BOB-3550

FIRE EXIT

+100 PCC FROM  
MM150 LVL WITH  
CORNER GUARD

LVL+150


LVL+38

LVL+150



LVL+250

"CORNER GUARD"  
DETAIL-A

+100 PCC FROM  
MM150 LVL WITH  
CORNER GUARD

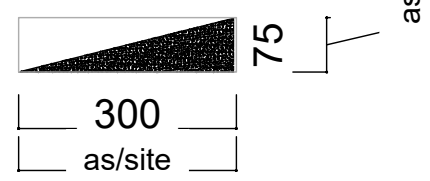

NOTE:- FLOOR TO BE RAISED AS PER SITE CONDITION. AVOID RAISING FLOOR IF NOT REQUIRE.

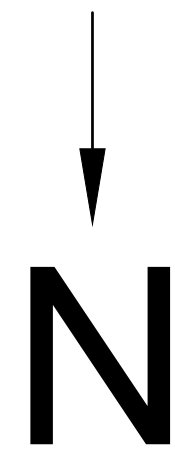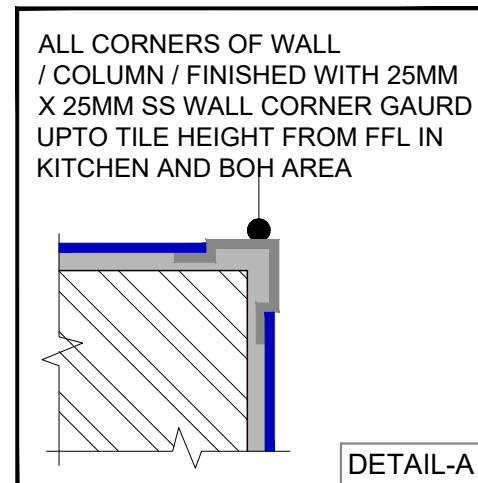

JUBILANT FOODWORKS LTD.  
(DOMINO'S PIZZA INDIA LTD.)  
LOGIX TECHNO PARK, PLOT NO. 5,  
TOWER - D, 5th FLOOR,  
SECTOR - 127, NOIDA-201304.  
PHONE: 0120-4090500, 4090594.

THESE PLANS & SPECIFICATIONS AS WELL AS DOMINO'S NAME & LOGO, TRADEMARKS & DESIGNS ARE THE EXCLUSIVE PROPERTY OF JUBILANT COMPANY. ANY REPRODUCTION, MODIFICATION, DISCLOSURE AND/OR USE OF THESE MATERIALS (OR BY PORTION OF THEM) WITHOUT DOMINO'S PRIOR WRITTEN CONSENT IS STRICTLY PROHIBITED.

DISCLAIMER-  
IN CASE OF ANY SITE DISCREPANCY,  
PLEASE GET BACK TO CORPORATE  
DESIGN TEAM

JUBILANT FOODWORKS  
INDIA LTD.

PROJ :UNA. HIMACHAL  
:PREDESH  
ZONE : NORTH  
COUNTRY : INDIA.

RESTAURANT NO.:

TOTAL CARPET AREA : 631 SQ.FT.  
CUSTOMER AREA : SQ.FT.  
KITCHEN AREA : 405 SQ.FT.  
BOH AREA : 236 SQ.FT.  
NO. OF COVERS :  
BOTTOM OF SLAB : 3734  
BOTTOM OF BEAM : 3110 & 3445  
SHUTTER OPENING HT.:

DRAWN BY : VARUN

CHECKED BY :

ISSUED ON : 22-01-2024

REVISION NO.	REVISION DATE
1	-2022
2	-2022
3	-2022
4	-2022

REMARKS :


SCALE : NOT TO SCALE.

SHEET NO. : 3

SHEET TITLE : CIVIL PLAN

SKIRTING LEGEND ( GROUND FLOOR)	
INDICATION	MAKE
FF 01	100MM HIGH -KAJARIA - COOL CEMENT
FF 02	100MM HIGH-KAJARIA - TERRAZZO GREY
FF 04	100MM HIGH - KAJARIA - SHEESHAM NERO

NOTE : 1) SKIRTING TO BE FLUSHED TO FINISHED WALL, PARTITION & PANELING WITH 6X6MM GROOVE

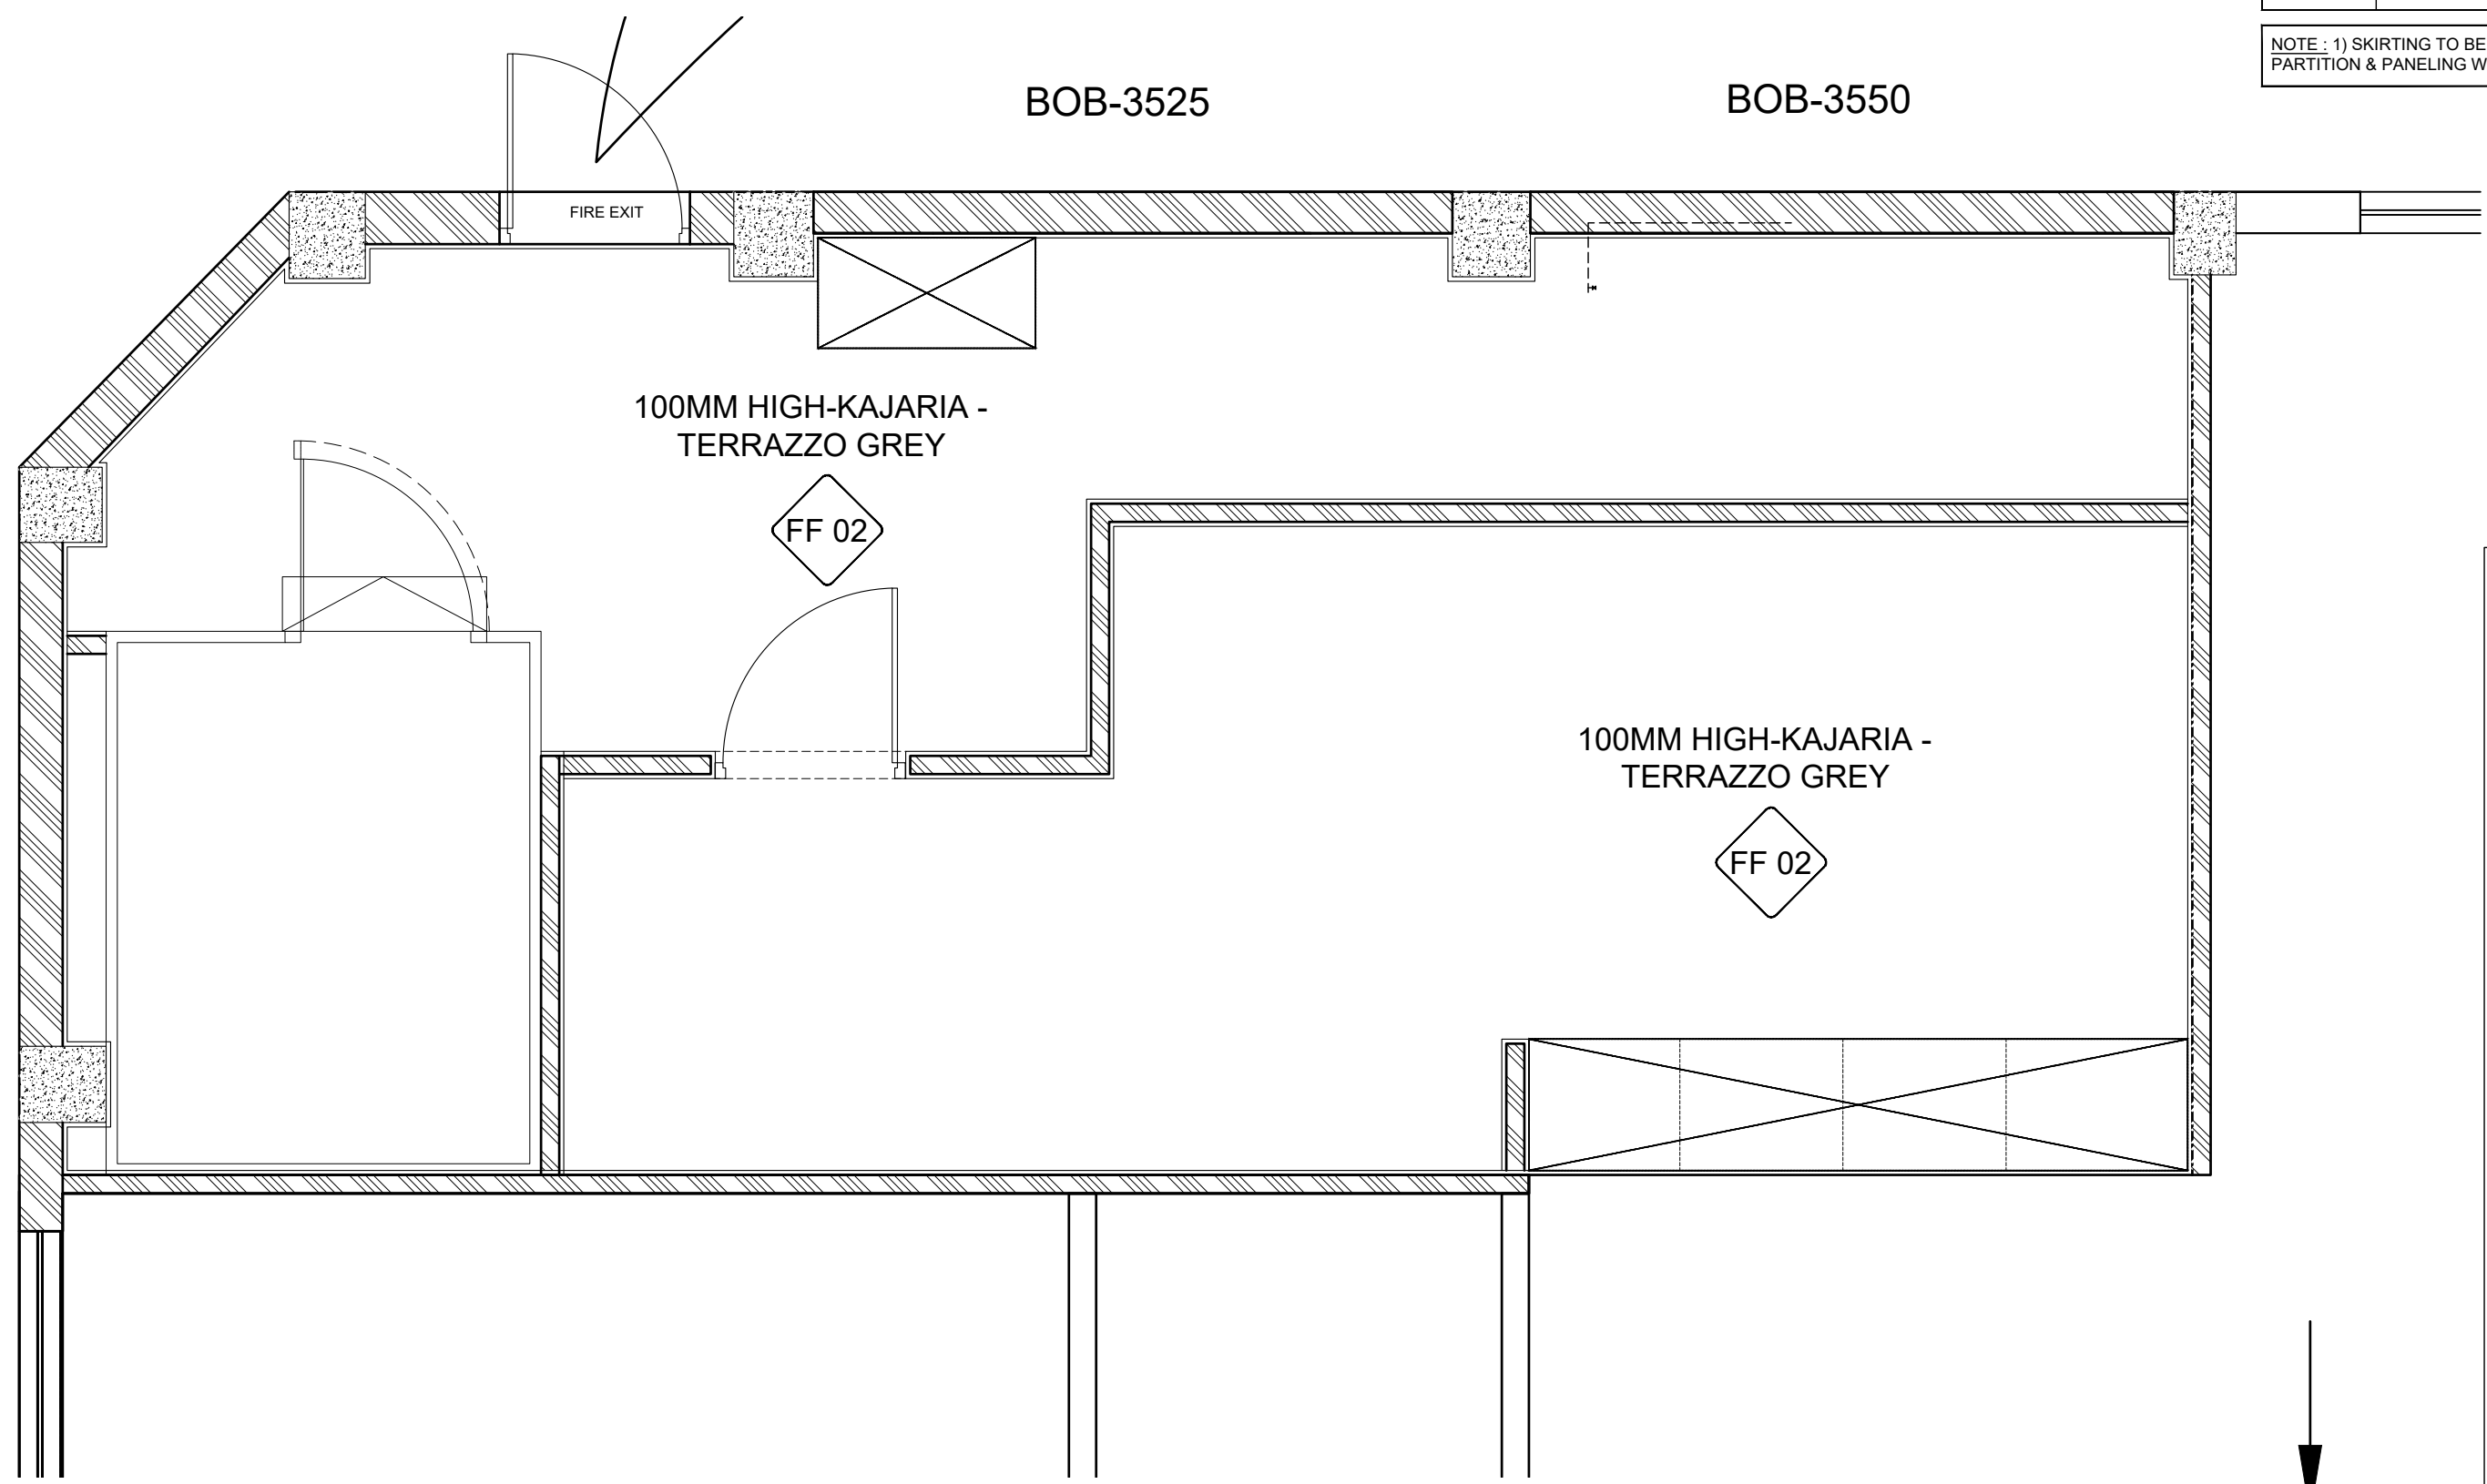

JUBILANT FOODWORKS LTD.  
(DOMINO'S PIZZA INDIA LTD.)  
LOGIX TECHNO PARK, PLOT NO. 5,  
TOWER - D, 5th FLOOR,  
SECTOR - 127, NOIDA-201304.  
PHONE: 0120-4090500, 4090594.

THESE PLANS & SPECIFICATIONS AS WELL AS DOMINO'S NAME & LOGO, TRADEMARKS & DESIGNS ARE THE EXCLUSIVE PROPERTY OF JUBILANT COMPANY. ANY REPRODUCTION, MODIFICATION, DISCLOSURE AND/OR USE OF THESE MATERIALS (OR BY PORTION OF THEM) WITHOUT DOMINO'S PRIOR WRITTEN CONSENT IS STRICTLY PROHIBITED.

DISCLAIMER-  
IN CASE OF ANY SITE DISCREPANCY,  
PLEASE GET BACK TO CORPORATE  
DESIGN TEAM

JUBILANT FOODWORKS  
INDIA LTD.

PROJ :UNA. HIMACHAL  
:PREDESH  
ZONE : NORTH  
COUNTRY : INDIA.

RESTAURANT NO.: .

TOTAL CARPET AREA : 631 SQ.FT.  
CUSTOMER AREA : SQ.FT.  
KITCHEN AREA : 405 SQ.FT.  
BOH AREA : 236 SQ.FT.  
NO. OF COVERS :  
BOTTOM OF SLAB : 3734  
BOTTOM OF BEAM : 3110 & 3445  
SHUTTER OPENING HT.:----

DRAWN BY : VARUN

CHECKED BY :

ISSUED ON : 22-01-2024


REVISION NO.	REVISION DATE
1	-2022
2	-2022
3	-2022
4	-2022


 
REMARKS :



SCALE : NOT TO SCALE.

SHEET NO. : 4

SHEET TITLE : SKIRTING PLAN

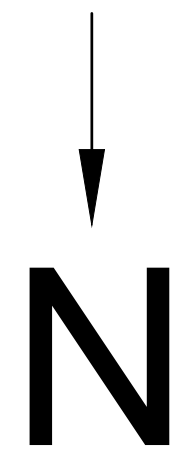

FLOORING LEGEND		
INDICATION	SIZE	MAKE
 FF 02	600 X 600	100MM HIGH-KAJARIA - TERRAZZO GREY
		DOOR JAMB TO BE FINISHED WITH BLACK GRANITE

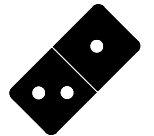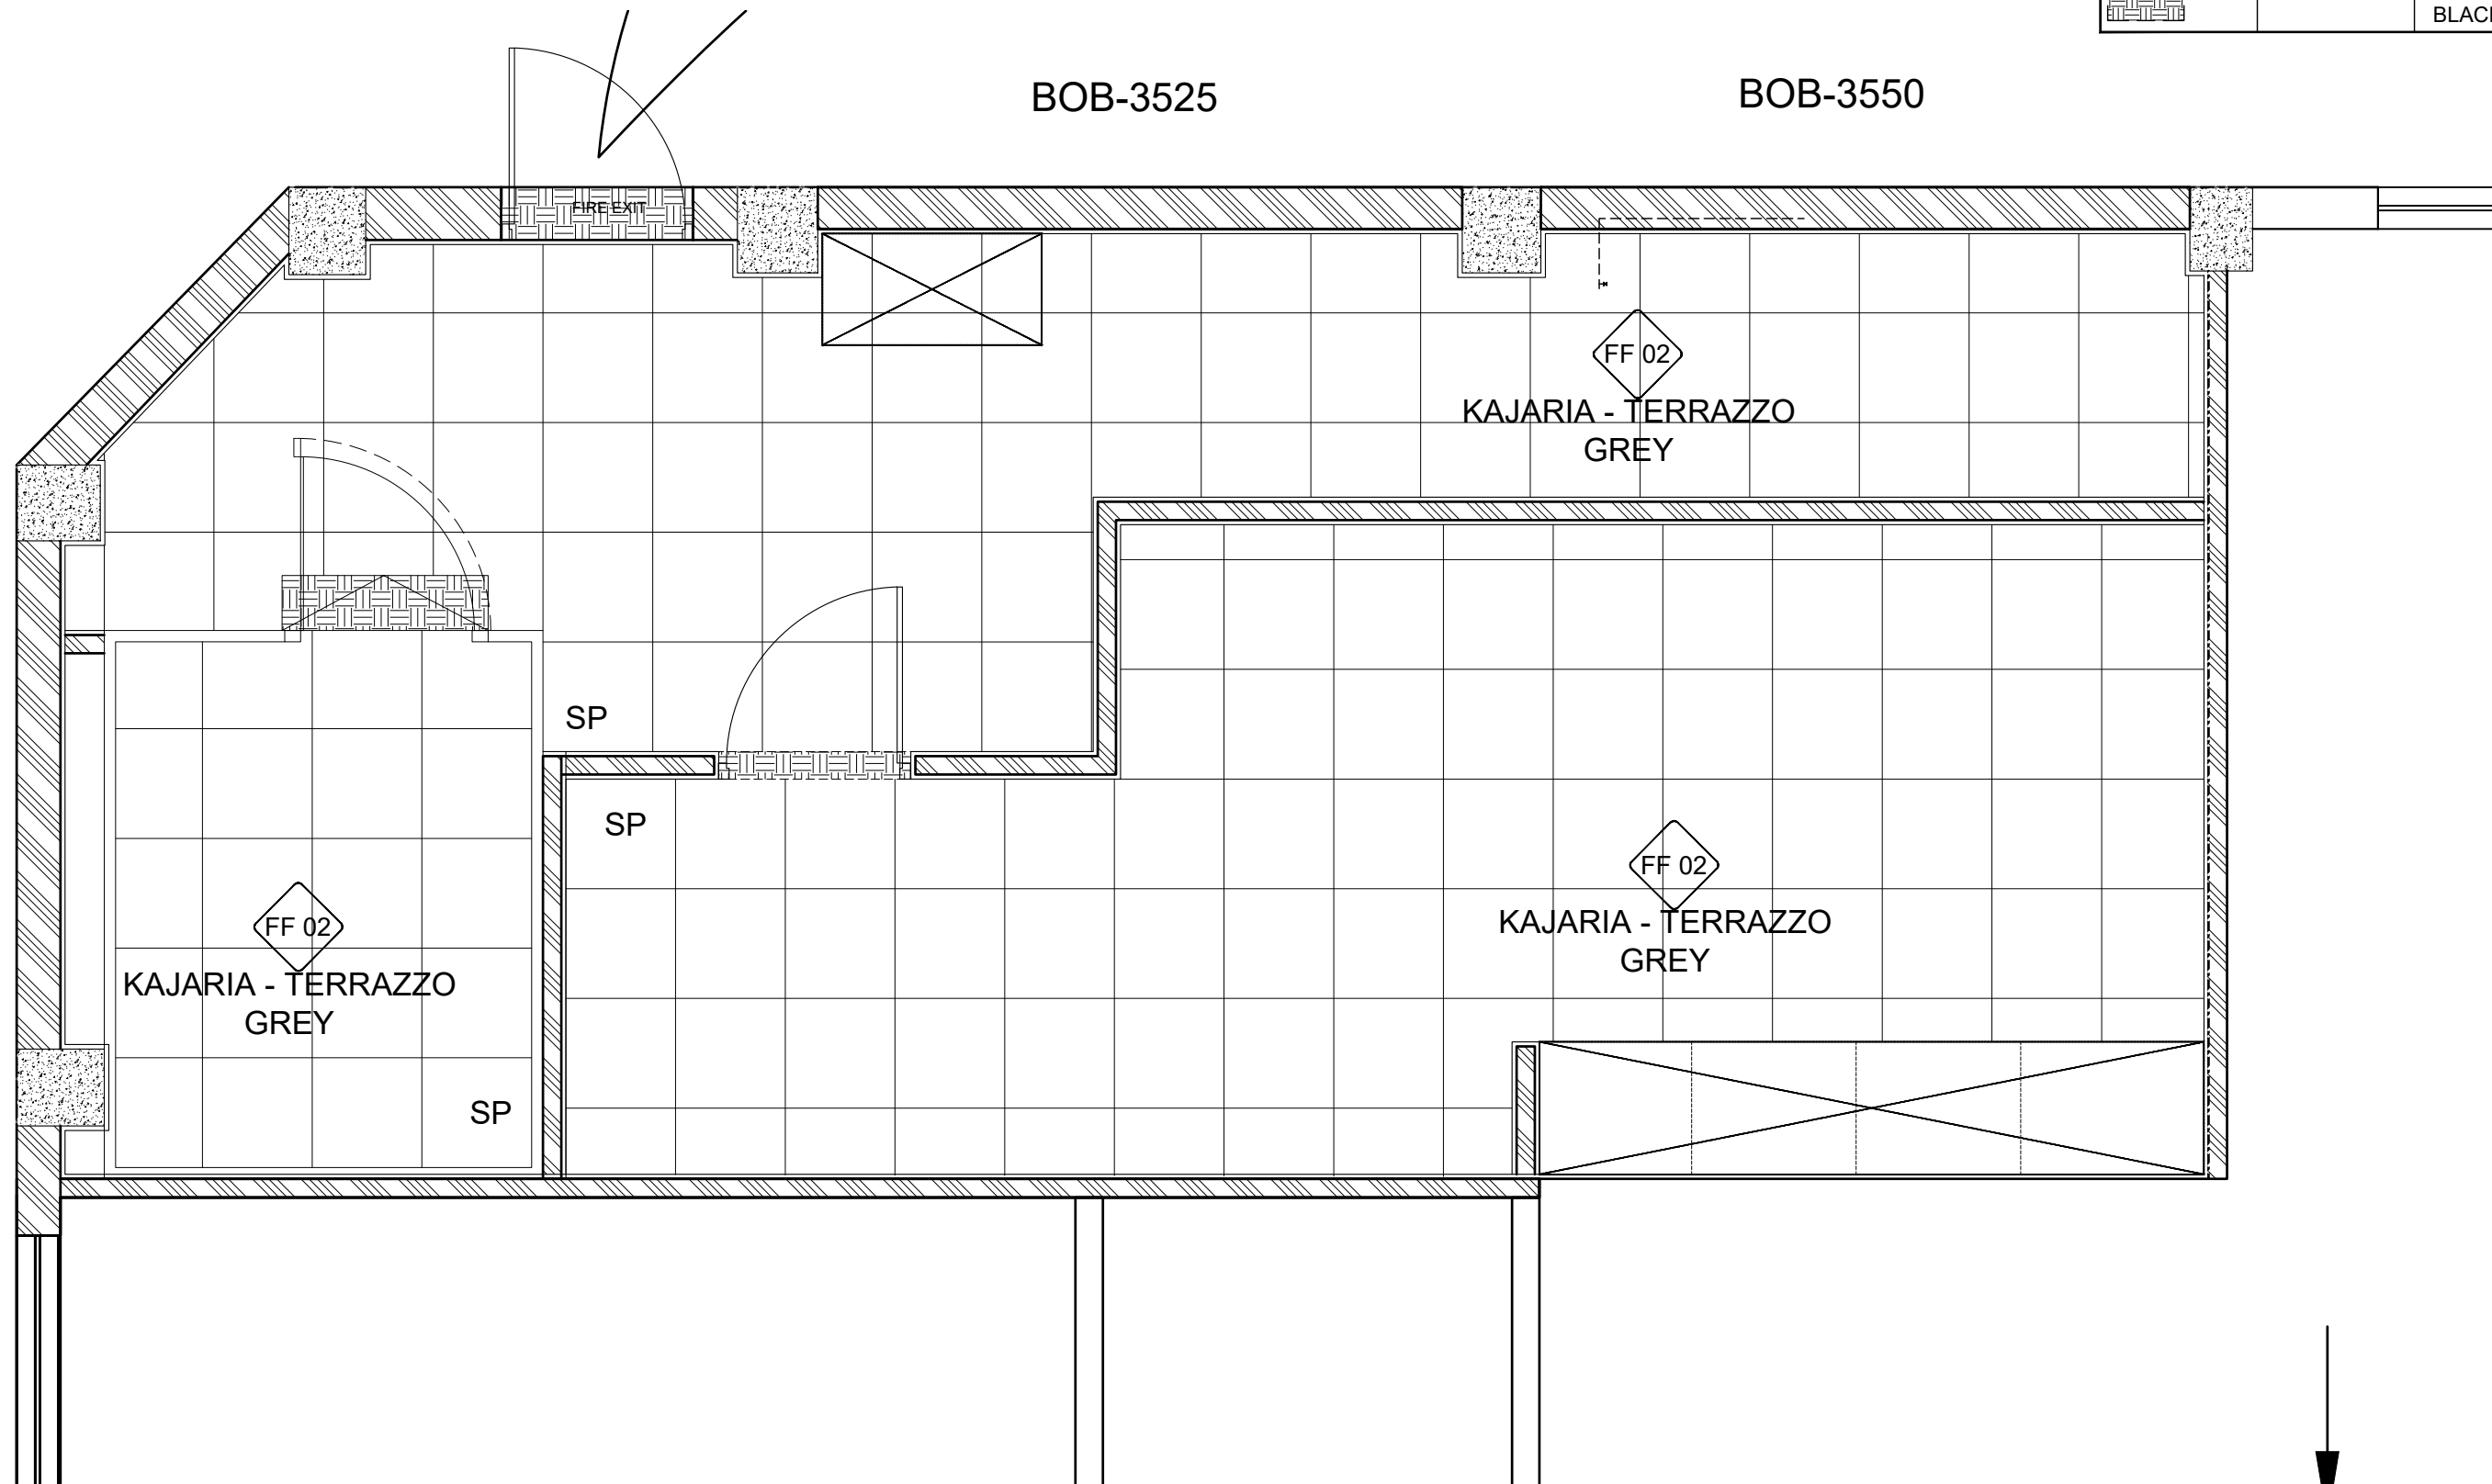

Domino's  
Pizza

JUBILANT FOODWORKS LTD.  
(DOMINO'S PIZZA INDIA LTD.)  
LOGIX TECHNO PARK, PLOT NO. 5,  
TOWER - D, 5th FLOOR,  
SECTOR - 127, NOIDA-201304.  
PHONE: 0120-4090500, 4090594.

THESE PLANS & SPECIFICATIONS AS WELL AS DOMINO'S  
NAME & LOGO, TRADEMARKS & DESIGNS ARE THE EXCLUSIVE  
PROPERTY OF JUBILANT COMPANY. ANY REPRODUCTION,  
MODIFICATION, DISCLOSURE AND/OR USE OF THESE  
MATERIALS (OR BY PORTION OF THEM) WITHOUT DOMINO'S  
PRIOR WRITTEN CONSENT IS STRICTLY PROHIBITED.

DISCLAIMER-  
IN CASE OF ANY SITE DISCREPANCY,  
PLEASE GET BACK TO CORPORATE  
DESIGN TEAM

JUBILANT FOODWORKS  
INDIA LTD.

PROJ :UNA. HIMACHAL  
:PREDESH  
ZONE : NORTH  
COUNTRY : INDIA.

RESTAURANT NO.:

TOTAL CARPET AREA : 631 SQ.FT.  
CUSTOMER AREA : SQ.FT.  
KITCHEN AREA : 405 SQ.FT.  
BOH AREA : 236 SQ.FT.  
NO. OF COVERS :  
BOTTOM OF SLAB : 3734  
BOTTOM OF BEAM : 3110 & 3445  
SHUTTER OPENING HT.:----

DRAWN BY : VARUN

CHECKED BY :

ISSUED ON : 22-01-2024

REVISION NO.	REVISION DATE
1	-2022
2	-2022
3	-2022
4	-2022


REMARKS :

SCALE : NOT TO SCALE.

SHEET NO. : 4

SHEET TITLE : FLOORING PLAN



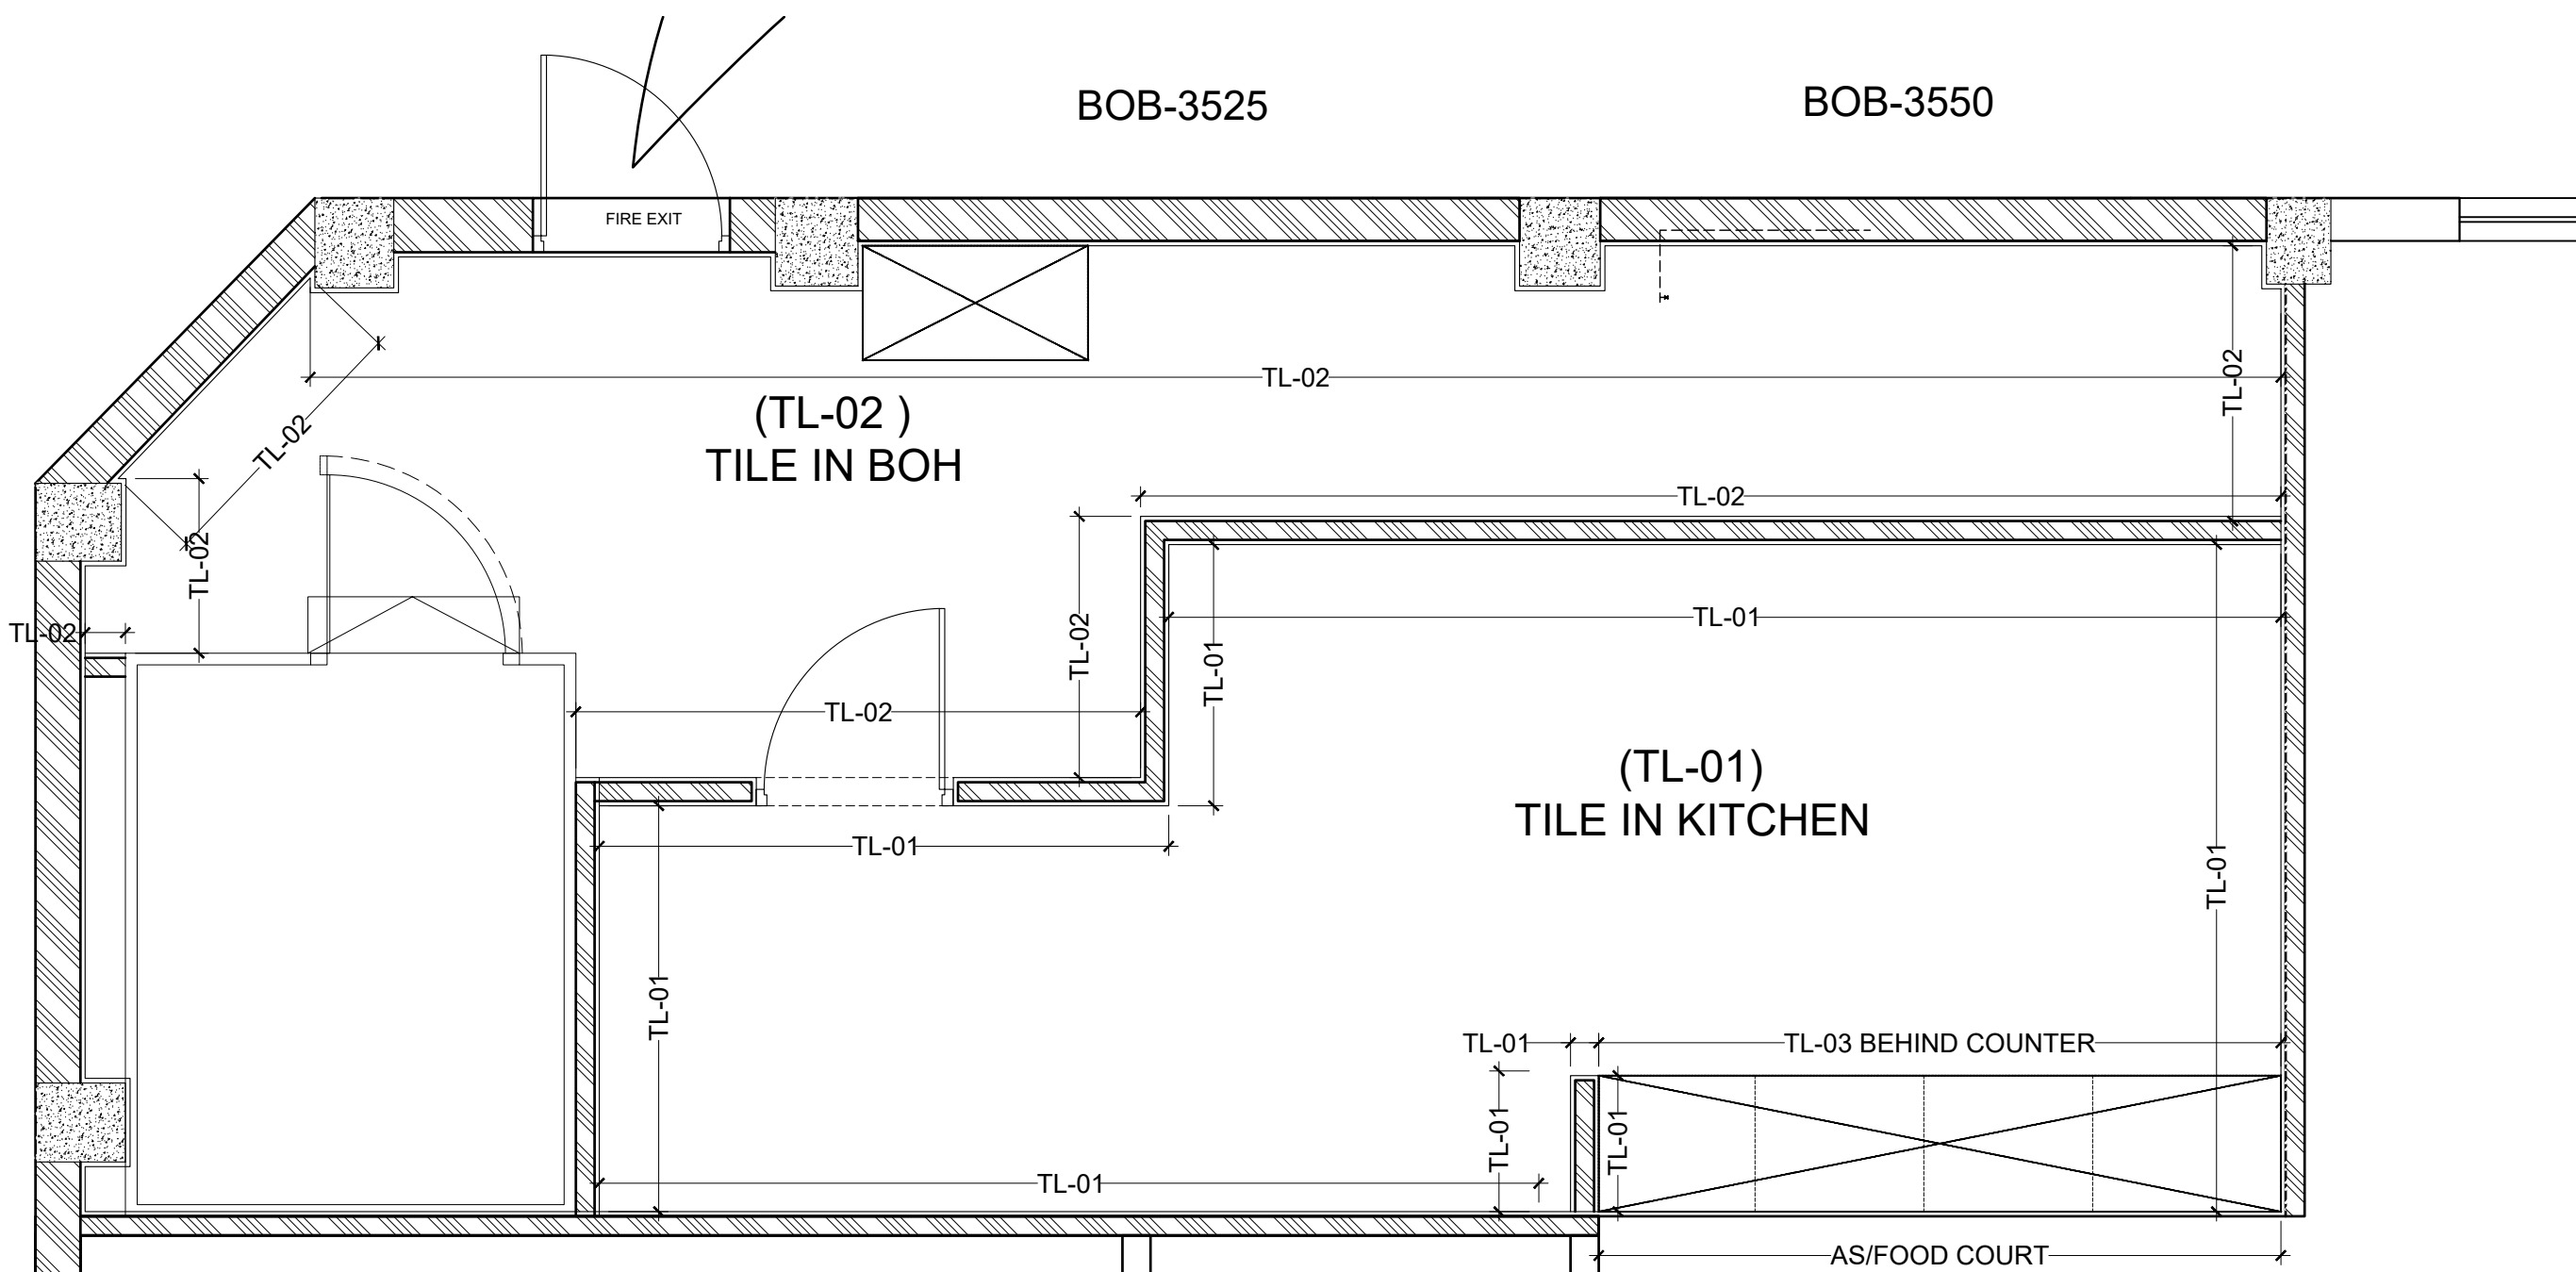

BOB-3525

BOB-3550

FIRE EXIT

(TL-02)  
TILE IN BOH


(TL-01)  
TILE IN KITCHEN

TL-03 BEHIND COUNTER

AS/FOOD COURT

STANDARD SCHEDULE OF MATERIALS

MATERIAL CODE	MATERIALS	FINISH / COLOUR	VENDOR / SUPPLIER
<b>PAINTS, LAMINATES &amp; VENEER</b>			
WF 01	Paint	COAL MINE 8301 ON CEILING	Asian Paints
LAM 01	Laminate	LOUISIANA OAK-5082	Greenlam
TL 01	600MM X 300MM TILE	LOFT TAUPE 300X600	Kajaria
TL 02	600MM X 300MM TILE	PLAIN BASE TILE OF PRINTED TILE TILL 7'-0" HEIGHT (BOH AREA)	Johnson
TL 03	600MM X 300MM TILE	LOFT TAUPE 300X600	Kajaria
ST-01	STONE	STEEL GREY	Granite
DADO	130X800 TILE	KAJARIA - 130X800MM SHEESHAM ROSEWOOD AS/ELEVATION	Kajaria

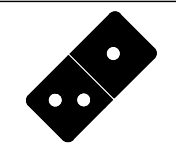

Domino's  
Pizza

JUBILANT FOODWORKS LTD.  
(DOMINO'S PIZZA INDIA LTD.)  
LOGIX TECHNO PARK, PLOT NO. 5,  
TOWER - D, 5th FLOOR,  
SECTOR - 127, NOIDA-201304.  
PHONE: 0120-4090500, 4090594.

THESE PLANS & SPECIFICATIONS AS WELL AS DOMINO'S NAME & LOGO, TRADEMARKS & DESIGNS ARE THE EXCLUSIVE PROPERTY OF JUBILANT COMPANY. ANY REPRODUCTION, MODIFICATION, DISCLOSURE AND/OR USE OF THESE MATERIALS (OR BY PORTION OF THEM) WITHOUT DOMINO'S PRIOR WRITTEN CONSENT IS STRICTLY PROHIBITED.

DISCLAIMER-  
IN CASE OF ANY SITE DISCREPANCY,  
PLEASE GET BACK TO CORPORATE  
DESIGN TEAM

JUBILANT FOODWORKS  
INDIA LTD.

PROJ :UNA. HIMACHAL  
:PREDESH  
ZONE : NORTH  
COUNTRY : INDIA.

RESTAURANT NO.:

TOTAL CARPET AREA : 631 SQ.FT.  
CUSTOMER AREA : SQ.FT.  
KITCHEN AREA : 405 SQ.FT.  
BOH AREA : 236 SQ.FT.  
NO. OF COVERS :  
BOTTOM OF SLAB : 3734  
BOTTOM OF BEAM : 3110 & 3445  
SHUTTER OPENING HT.:

DRAWN BY : VARUN

CHECKED BY :

ISSUED ON : 22-01-2024


REVISION NO.	REVISION DATE
1	-2022
2	-2022
3	-2022
4	-2022

REMARKS :


SCALE : NOT TO SCALE.

SHEET NO. : 5

SHEET TITLE : WALL DECORATION PLAN

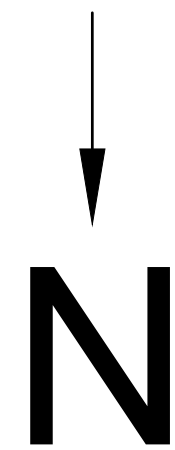


Manual/raw power db  
and ups bd 2x 8 way  
spn

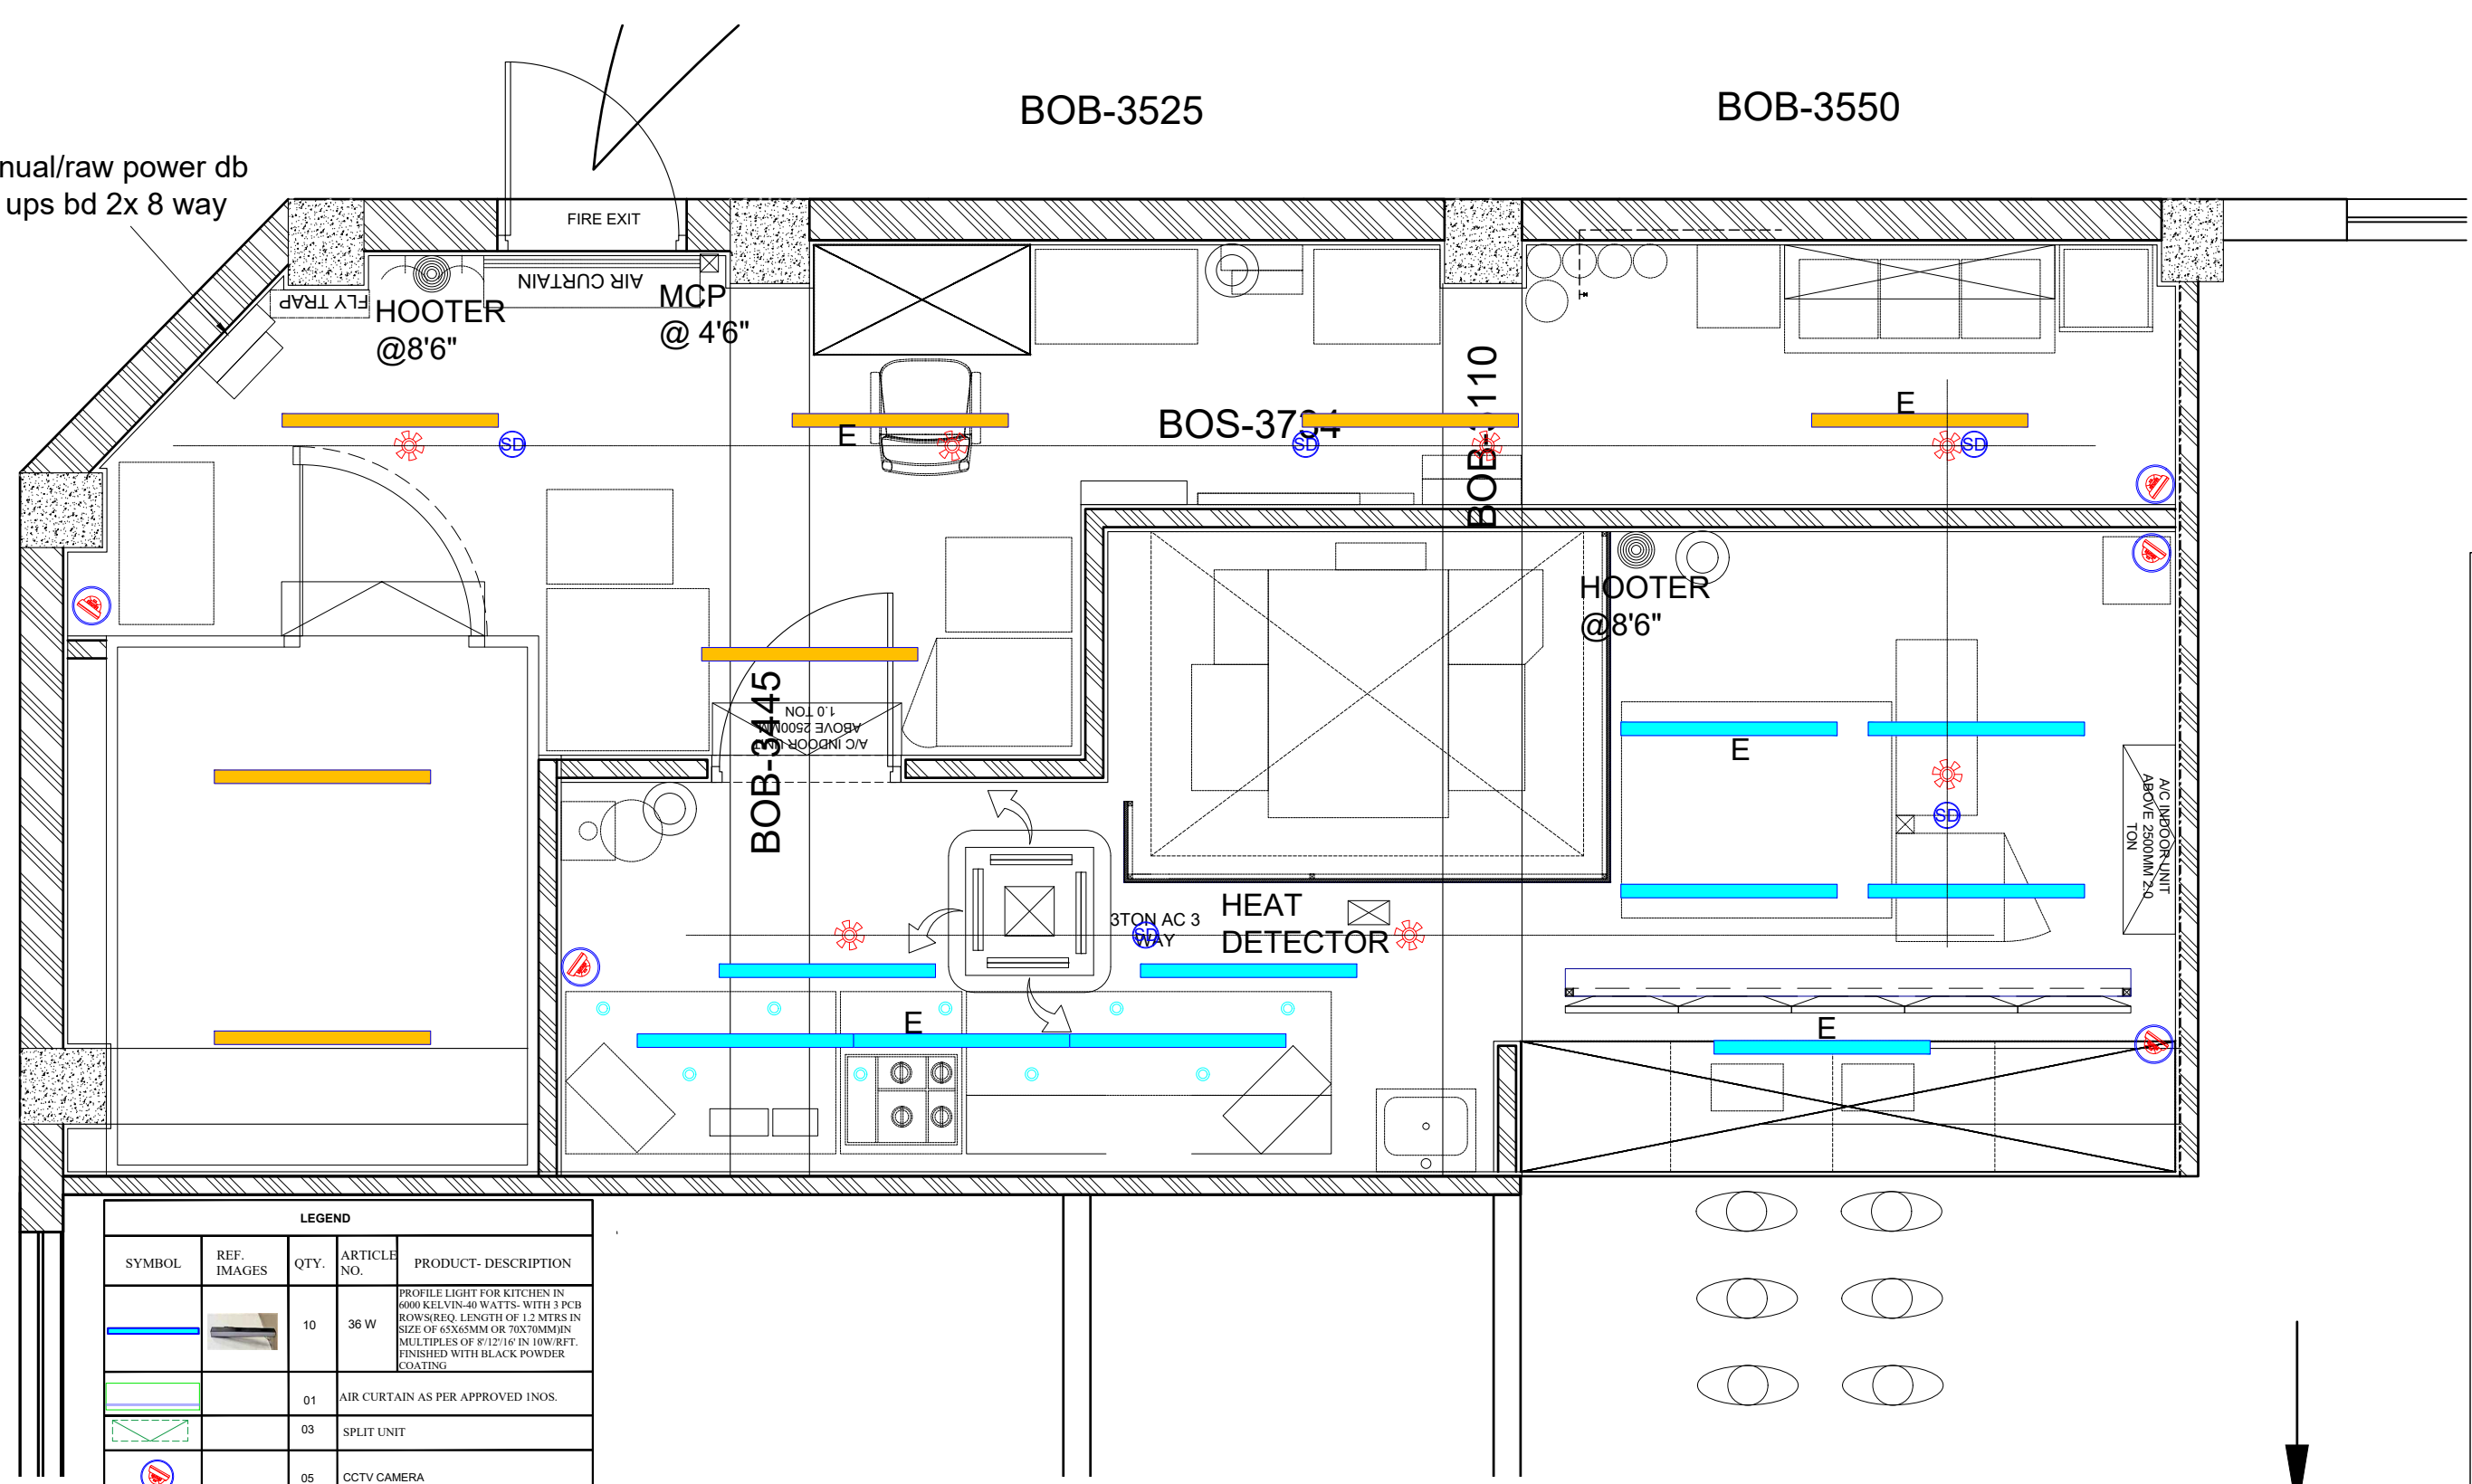

LEGEND				
SYMBOL	REF. IMAGES	QTY.	ARTICLE NO.	PRODUCT-DESCRIPTION
		10	36 W	PROFILE LIGHT FOR KITCHEN IN 6000 KELVIN-40 WATTS- WITH 3 PCB ROWS/REG. LENGTH OF 1.2 METRS IN SIZE OF 65X65MM OR 70X70MM/IN MULTIPLES OF 8'12'7'16" IN 10W/RF. FINISHED WITH BLACK POWDER COATING
		01		AIR CURTAIN AS PER APPROVED INOS.
		03		SPLIT UNIT
		05		CCTV CAMERA
		07		SPRINKLER
		05		SMOKE DETECTOR
		07		NORMAL TS LIGHT
		09		DECO PENDANT LIGHT FOR KITCHEN IN 6000KELVIN/LED BULB OF 6 WATTS IN 3"-4"HT. WITH B22 HOLDER. INDOOR FIXTURE
		E		EMERGENCY LIGHT
		01		4-WAY CASSETTE UNIT

LIGHT BOTTOM SHOULD BE IN LINE WITH TILES TOP

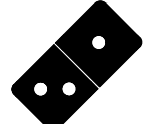

**Domino's  
Pizza**

JUBILANT FOODWORKS LTD.  
(DOMINO'S PIZZA INDIA LTD.)  
LOGIX TECHNO PARK, PLOT NO. 5,  
TOWER - D, 5th FLOOR,  
SECTOR - 127, NOIDA-201304.  
PHONE: 0120-4090500, 4090594.

THESE PLANS & SPECIFICATIONS AS WELL AS DOMINO'S NAME & LOGO, TRADEMARKS & DESIGNS ARE THE EXCLUSIVE PROPERTY OF JUBILANT COMPANY. ANY REPRODUCTION, MODIFICATION, DISCLOSURE AND/OR USE OF THESE MATERIALS (OR BY PORTION OF THEM) WITHOUT DOMINO'S PRIOR WRITTEN CONSENT IS STRICTLY PROHIBITED.

**DISCLAIMER-**  
IN CASE OF ANY SITE DISCREPANCY,  
PLEASE GET BACK TO CORPORATE  
DESIGN TEAM

JUBILANT FOODWORKS  
INDIA LTD.

PROJ :UNA. HIMACHAL  
:PREDESH  
ZONE : NORTH  
COUNTRY : INDIA.


RESTAURANT NO.:..

TOTAL CARPET AREA : 631 SQ.FT.  
CUSTOMER AREA : SQ.FT.  
KITCHEN AREA : 405 SQ.FT.  
BOH AREA : 236 SQ.FT.  
NO. OF COVERS :  
BOTTOM OF SLAB : 3734  
BOTTOM OF BEAM : 3110 & 3445  
SHUTTER OPENING HT.:----

DRAWN BY : VARUN  
CHECKED BY :  
ISSUED ON : 22-01-2024

REVISION NO.	REVISION DATE
1	-2022
2	-2022
3	-2022
4	-2022


REMARKS :  
SCALE : NOT TO SCALE.  
SHEET NO. : 7  
SHEET TITLE : RCP PLAN

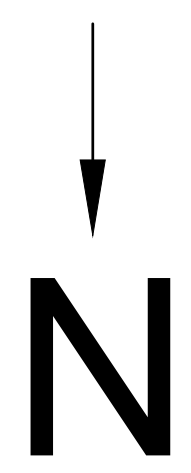

Manual/raw power db  
and ups bd 2x 8 way  
spn

BOB-3525

BOB-3550

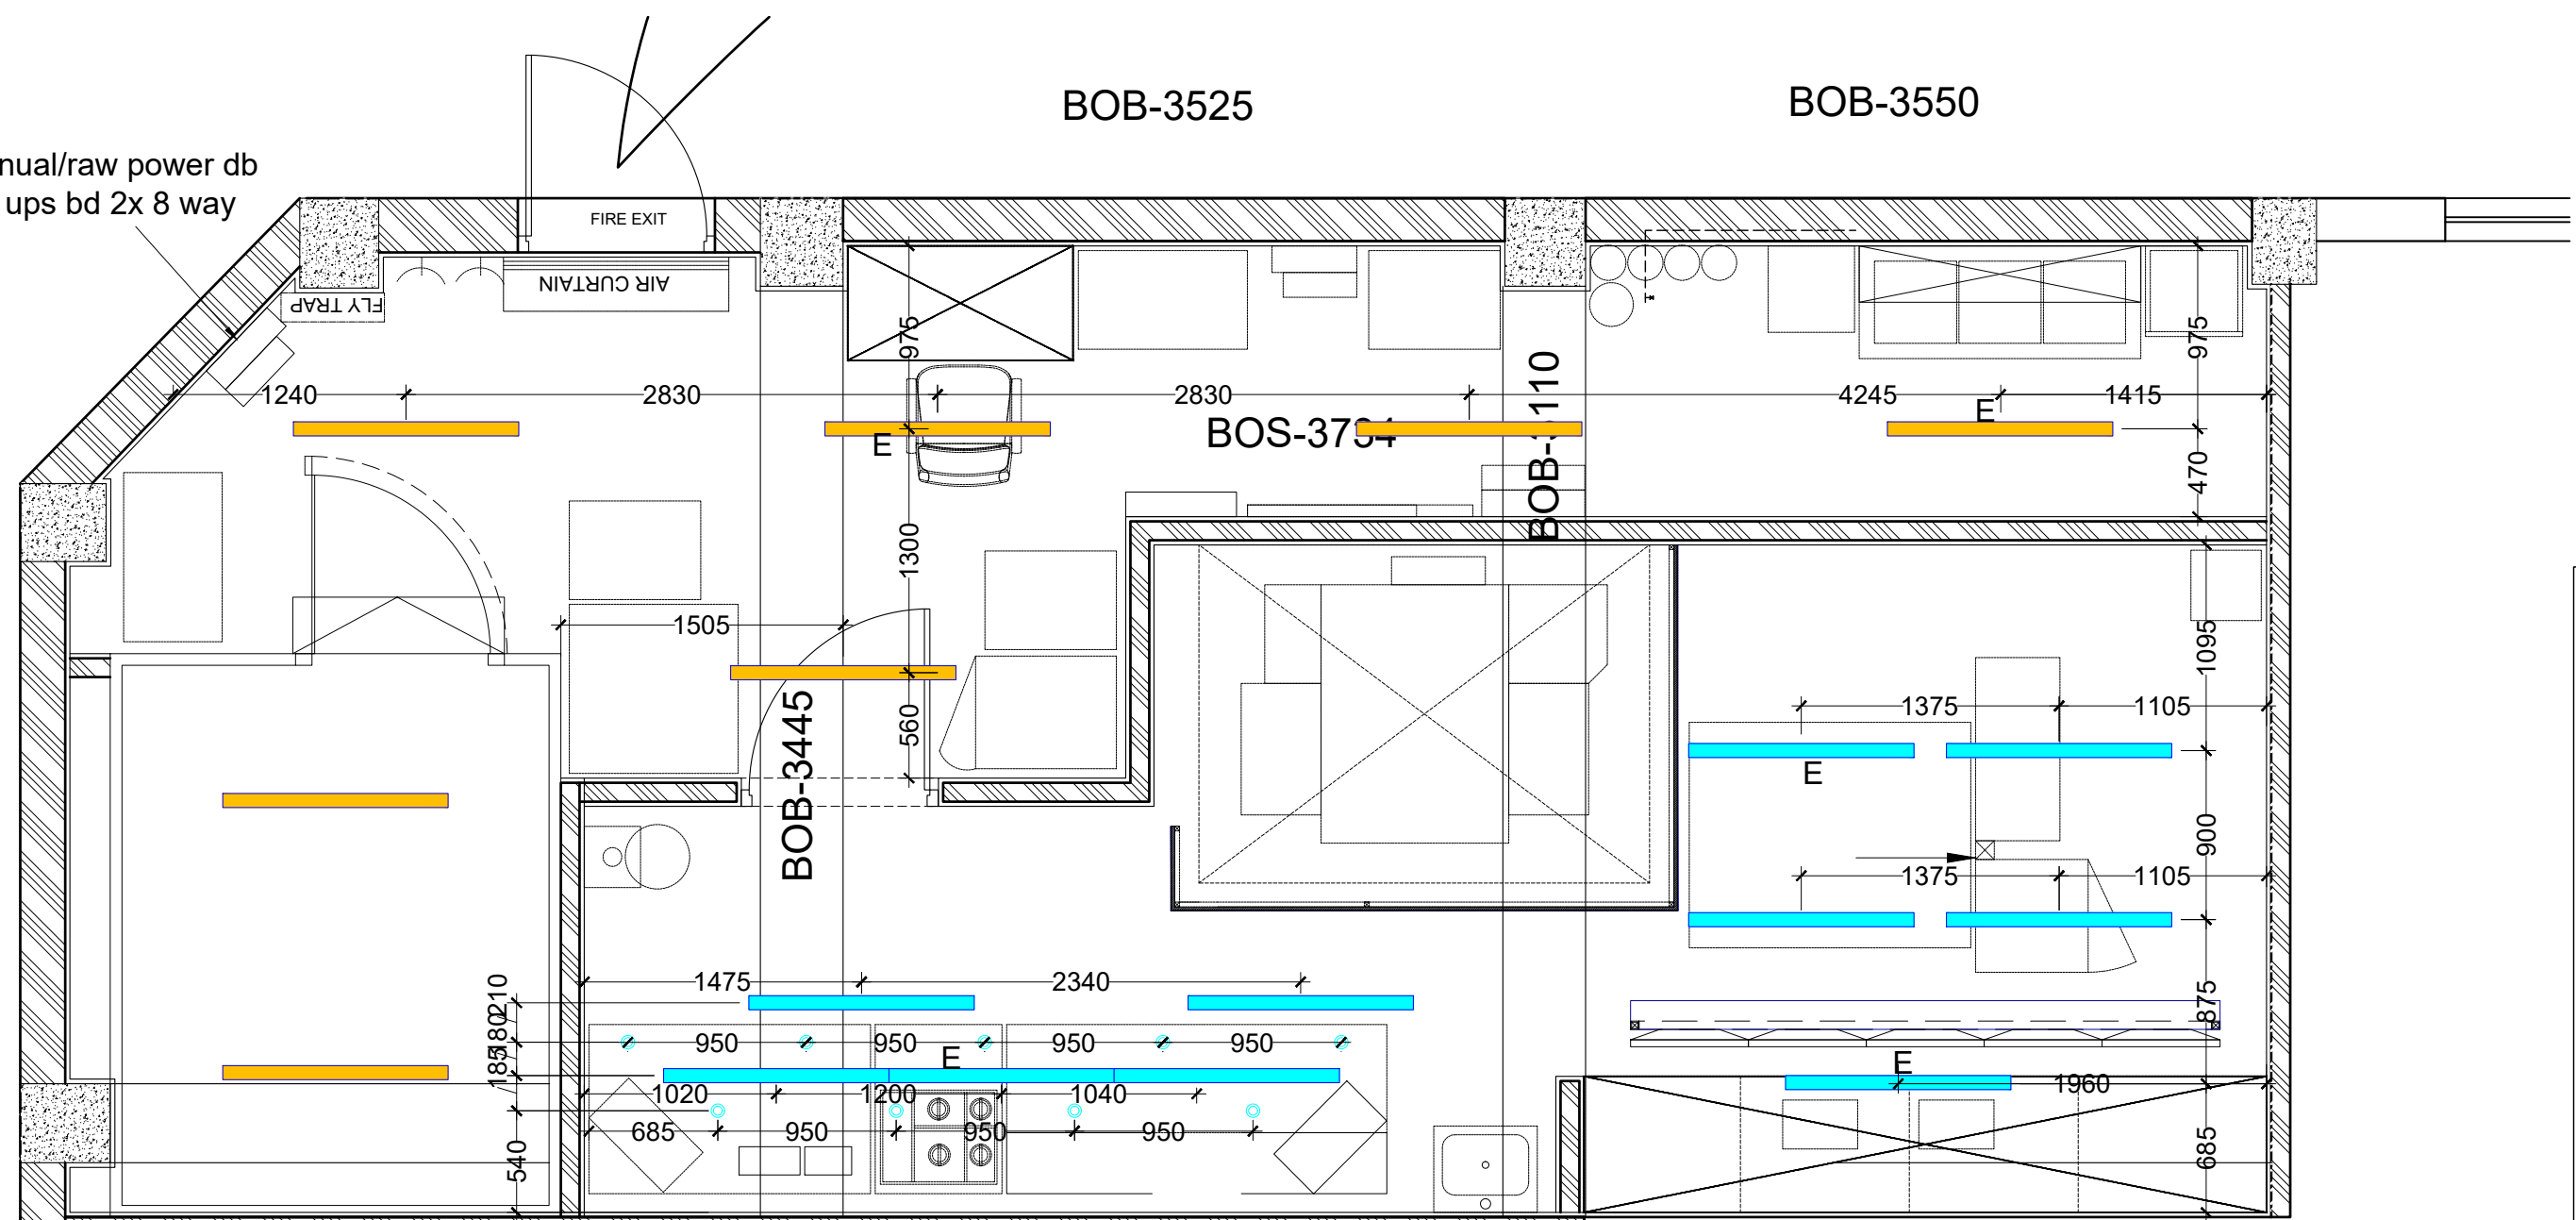

LEGEND				
SYMBOL	REF. IMAGES	QTY.	ARTICLE NO.	PRODUCT-DESCRIPTION
		10	36 W	PROFILE LIGHT FOR KITCHEN IN 6000 KELVIN-40 WATTS- WITH 3 PCB ROWS/REG. LENGTH OF 1.2 METRS IN SIZE OF 65x65MM OR 70x70MM/IN. MULTIPLES OF 8'12"/16" IN 10W/RF. FINISHED WITH BLACK POWDER COATING
		01		AIR CURTAIN AS PER APPROVED INOS.
		03		SPLIT UNIT
		05		CCTV CAMERA
		07		SPRINKLER
		05		SMOKE DETECTOR
		07		NORMAL TS LIGHT
		09		DECO PENDANT LIGHT FOR KITCHEN IN 6000KELVIN/LED BULB OF 6 WATTS IN 3"-4"HT. WITH B22 HOLDER. INDOOR FIXTURE
		E		EMERGENCY LIGHT
		01		4-WAY CASSETTE UNIT



JUBILANT FOODWORKS LTD.  
(DOMINO'S PIZZA INDIA LTD.)  
LOGIX TECHNO PARK, PLOT NO. 5,  
TOWER - D, 5th FLOOR,  
SECTOR - 127, NOIDA-201304.  
PHONE: 0120-4090500, 4090594.

THESE PLANS & SPECIFICATIONS AS WELL AS DOMINO'S NAME & LOGO, TRADEMARKS & DESIGNS ARE THE EXCLUSIVE PROPERTY OF JUBILANT COMPANY. ANY REPRODUCTION, MODIFICATION, DISCLOSURE AND/OR USE OF THESE MATERIALS (OR BY PORTION OF THEM) WITHOUT DOMINO'S PRIOR WRITTEN CONSENT IS STRICTLY PROHIBITED.

DISCLAIMER-  
IN CASE OF ANY SITE DISCREPANCY,  
PLEASE GET BACK TO CORPORATE  
DESIGN TEAM

JUBILANT FOODWORKS  
INDIA LTD.


PROJ :UNA. HIMACHAL  
:PREDESH  
ZONE : NORTH  
COUNTRY : INDIA.

RESTAURANT NO.:..


TOTAL CARPET AREA : 631 SQ.FT.  
CUSTOMER AREA : SQ.FT.  
KITCHEN AREA : 405 SQ.FT.  
BOH AREA : 236 SQ.FT.  
NO. OF COVERS :  
BOTTOM OF SLAB : 3734  
BOTTOM OF BEAM : 3110 & 3445  
SHUTTER OPENING HT.:----

DRAWN BY	: VARUN
CHECKED BY	:
ISSUED ON	: 22-01-2024
REVISION NO.	REVISION DATE
1	-2022
2	-2022
3	-2022
4	-2022


REMARKS :  
SCALE : NOT TO SCALE.  
SHEET NO. : 8  
SHEET TITLE : LIGHTING PLAN

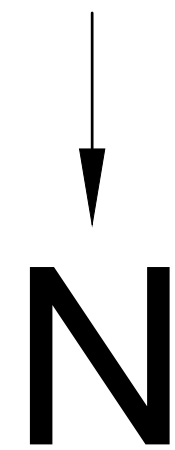



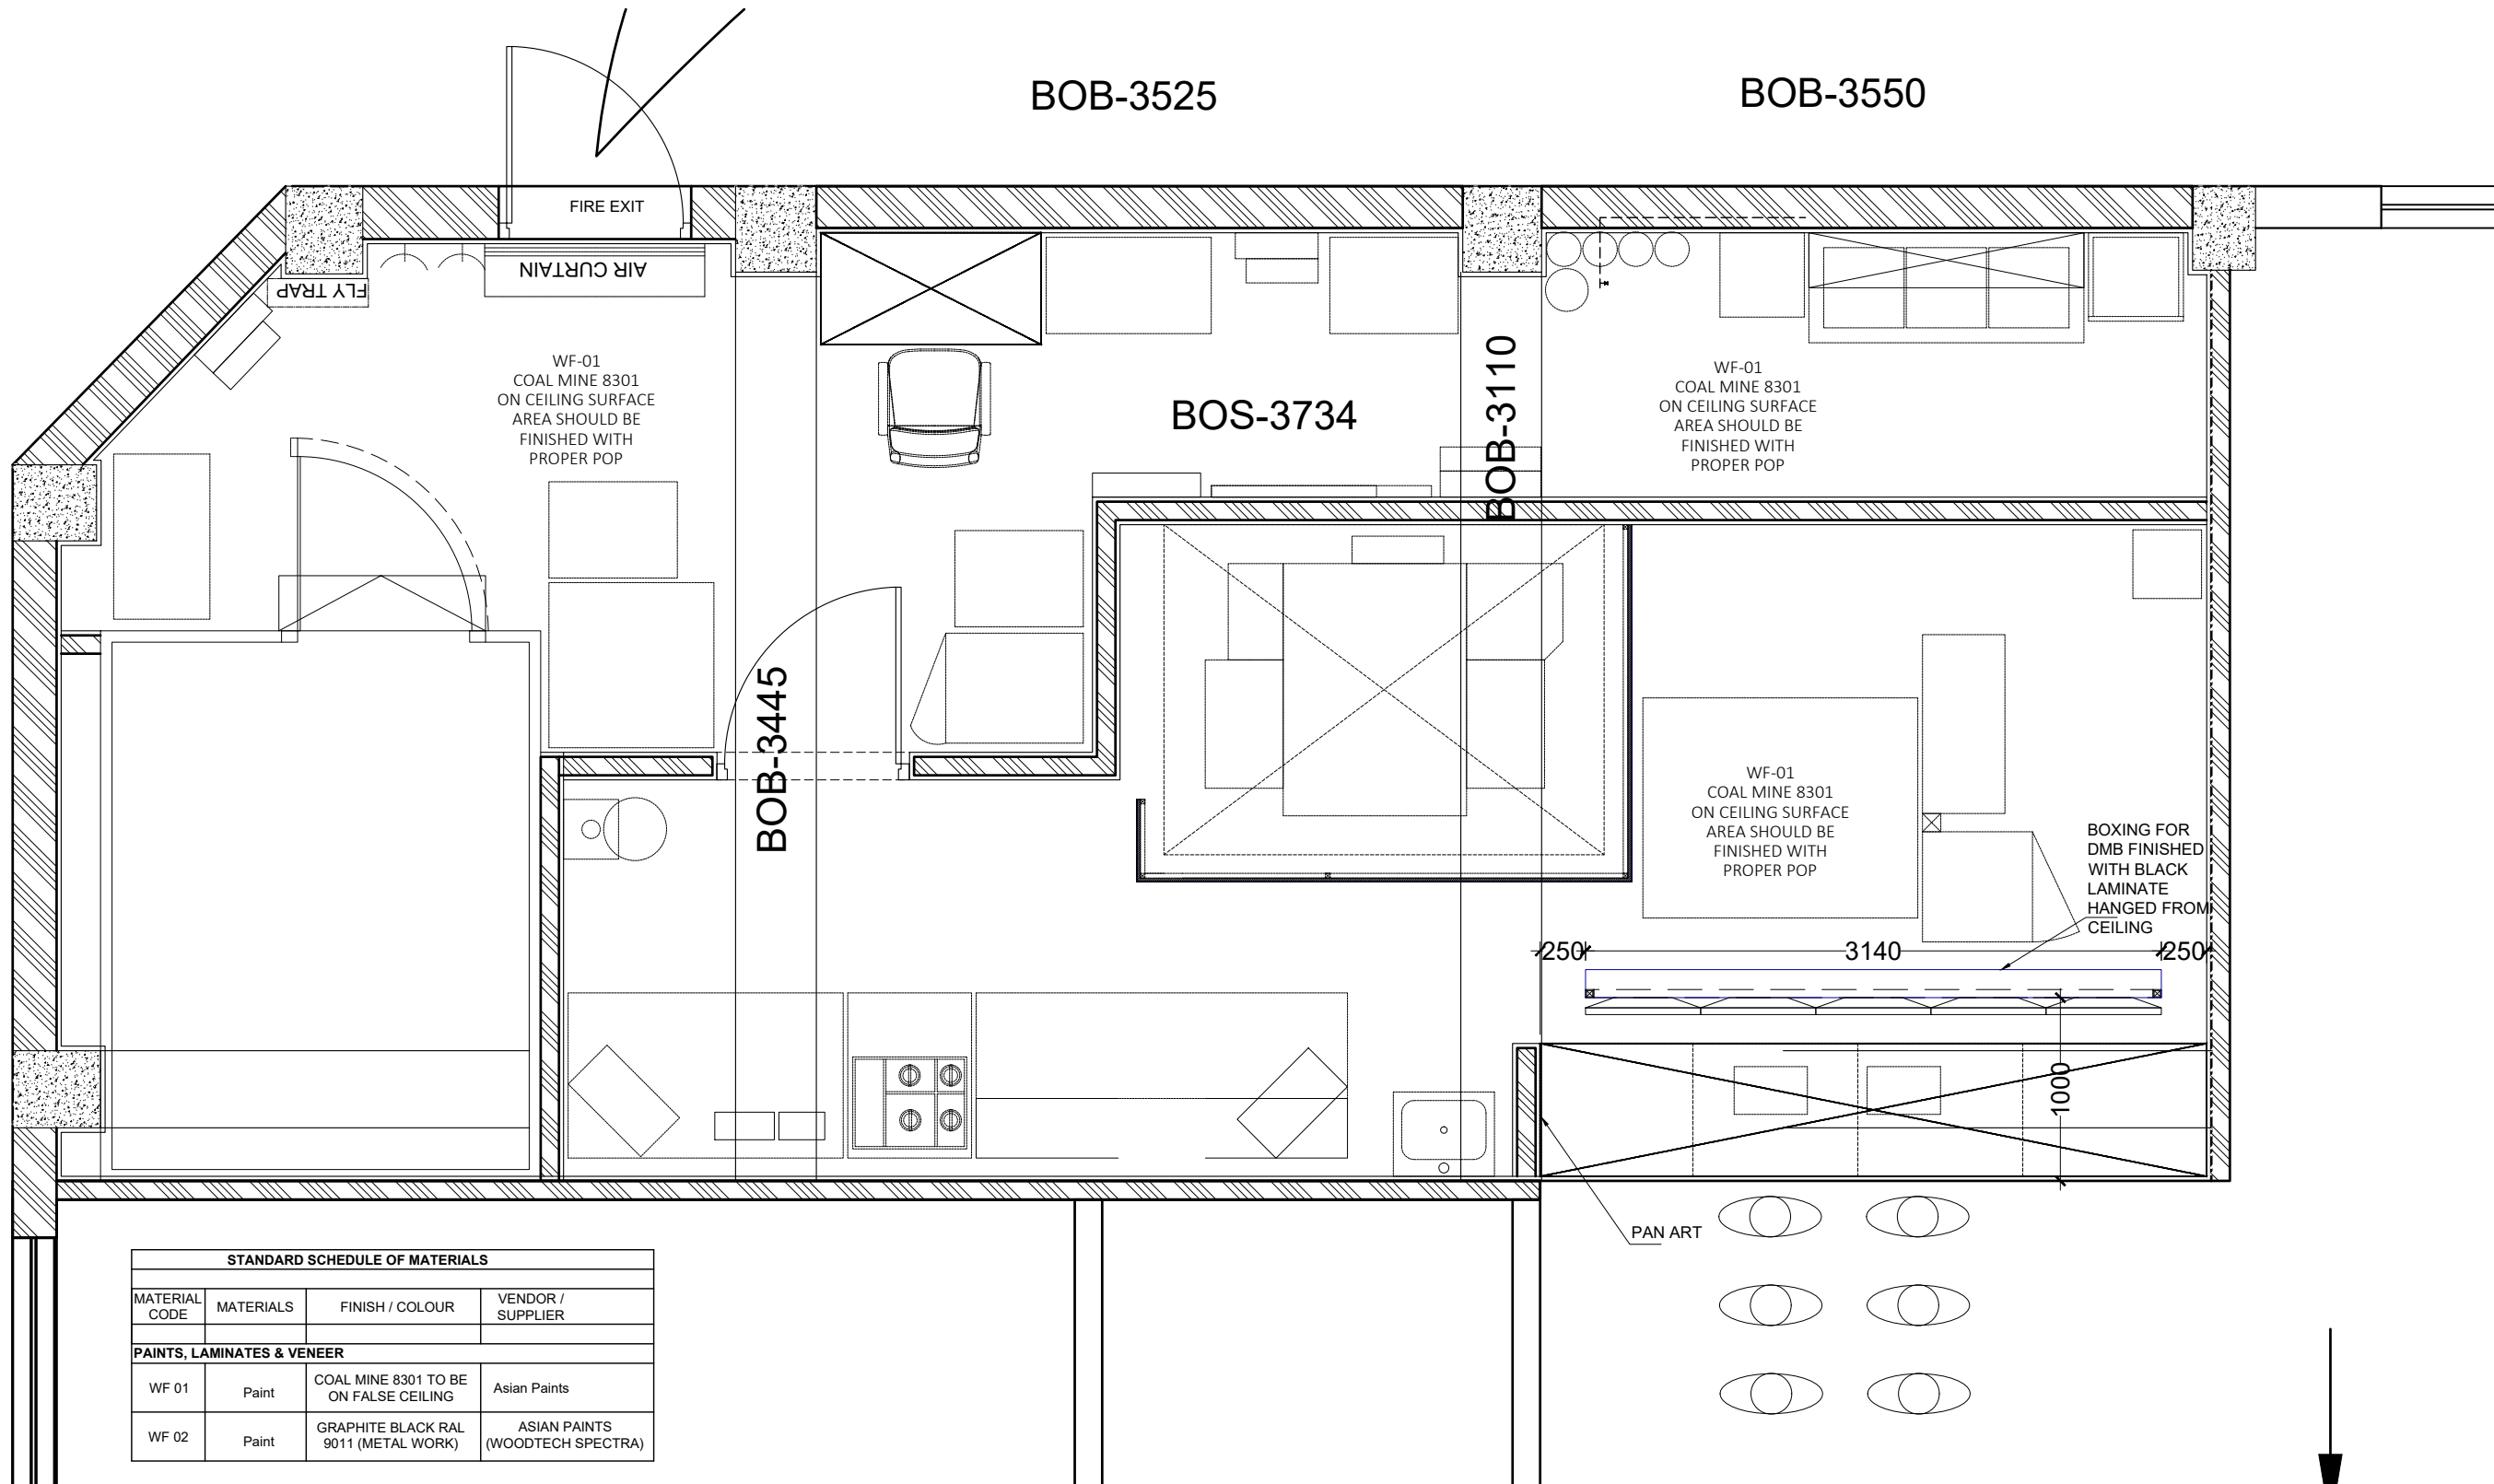

STANDARD SCHEDULE OF MATERIALS			
MATERIAL CODE	MATERIALS	FINISH / COLOUR	VENDOR / SUPPLIER
<b>PAINTS, LAMINATES &amp; VENEER</b>			
WF 01	Paint	COAL MINE 8301 TO BE ON FALSE CEILING	Asian Paints
WF 02	Paint	GRAPHITE BLACK RAL 9011 (METAL WORK)	ASIAN PAINTS (WOODTECH SPECTRA)

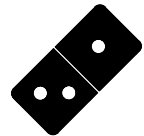

**Domino's  
Pizza**

JUBILANT FOODWORKS LTD.  
(DOMINO'S PIZZA INDIA LTD.)  
LOGIX TECHNO PARK, PLOT NO. 5,  
TOWER - D, 5th FLOOR,  
SECTOR - 127, NOIDA-201304.  
PHONE: 0120-4090500, 4090594.

THESE PLANS & SPECIFICATIONS AS WELL AS DOMINO'S NAME & LOGO, TRADEMARKS & DESIGNS ARE THE EXCLUSIVE PROPERTY OF JUBILANT COMPANY. ANY REPRODUCTION, MODIFICATION, DISCLOSURE AND/OR USE OF THESE MATERIALS (OR BY PORTION OF THEM) WITHOUT DOMINO'S PRIOR WRITTEN CONSENT IS STRICTLY PROHIBITED.

**DISCLAIMER-**  
IN CASE OF ANY SITE DISCREPANCY,  
PLEASE GET BACK TO CORPORATE  
DESIGN TEAM

JUBILANT FOODWORKS  
INDIA LTD.

PROJ :UNA. HIMACHAL  
:PREDESH  
ZONE : NORTH  
COUNTRY : INDIA.


RESTAURANT NO.: .


TOTAL CARPET AREA : 631 SQ.FT.  
CUSTOMER AREA : SQ.FT.  
KITCHEN AREA : 405 SQ.FT.  
BOH AREA : 236 SQ.FT.  
NO. OF COVERS :  
BOTTOM OF SLAB : 3734  
BOTTOM OF BEAM : 3110 & 3445  
SHUTTER OPENING HT.:----

DRAWN BY : VARUN  
CHECKED BY :  
ISSUED ON : 22-01-2024

REVISION NO.	REVISION DATE
1	-2022
2	-2022
3	-2022
4	-2022

REMARKS :  
SCALE : NOT TO SCALE.  
SHEET NO. : 9  
SHEET TITLE : CEILING PLAN

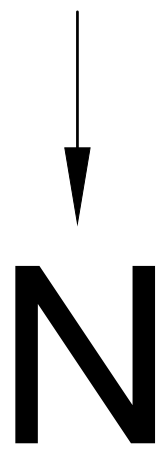

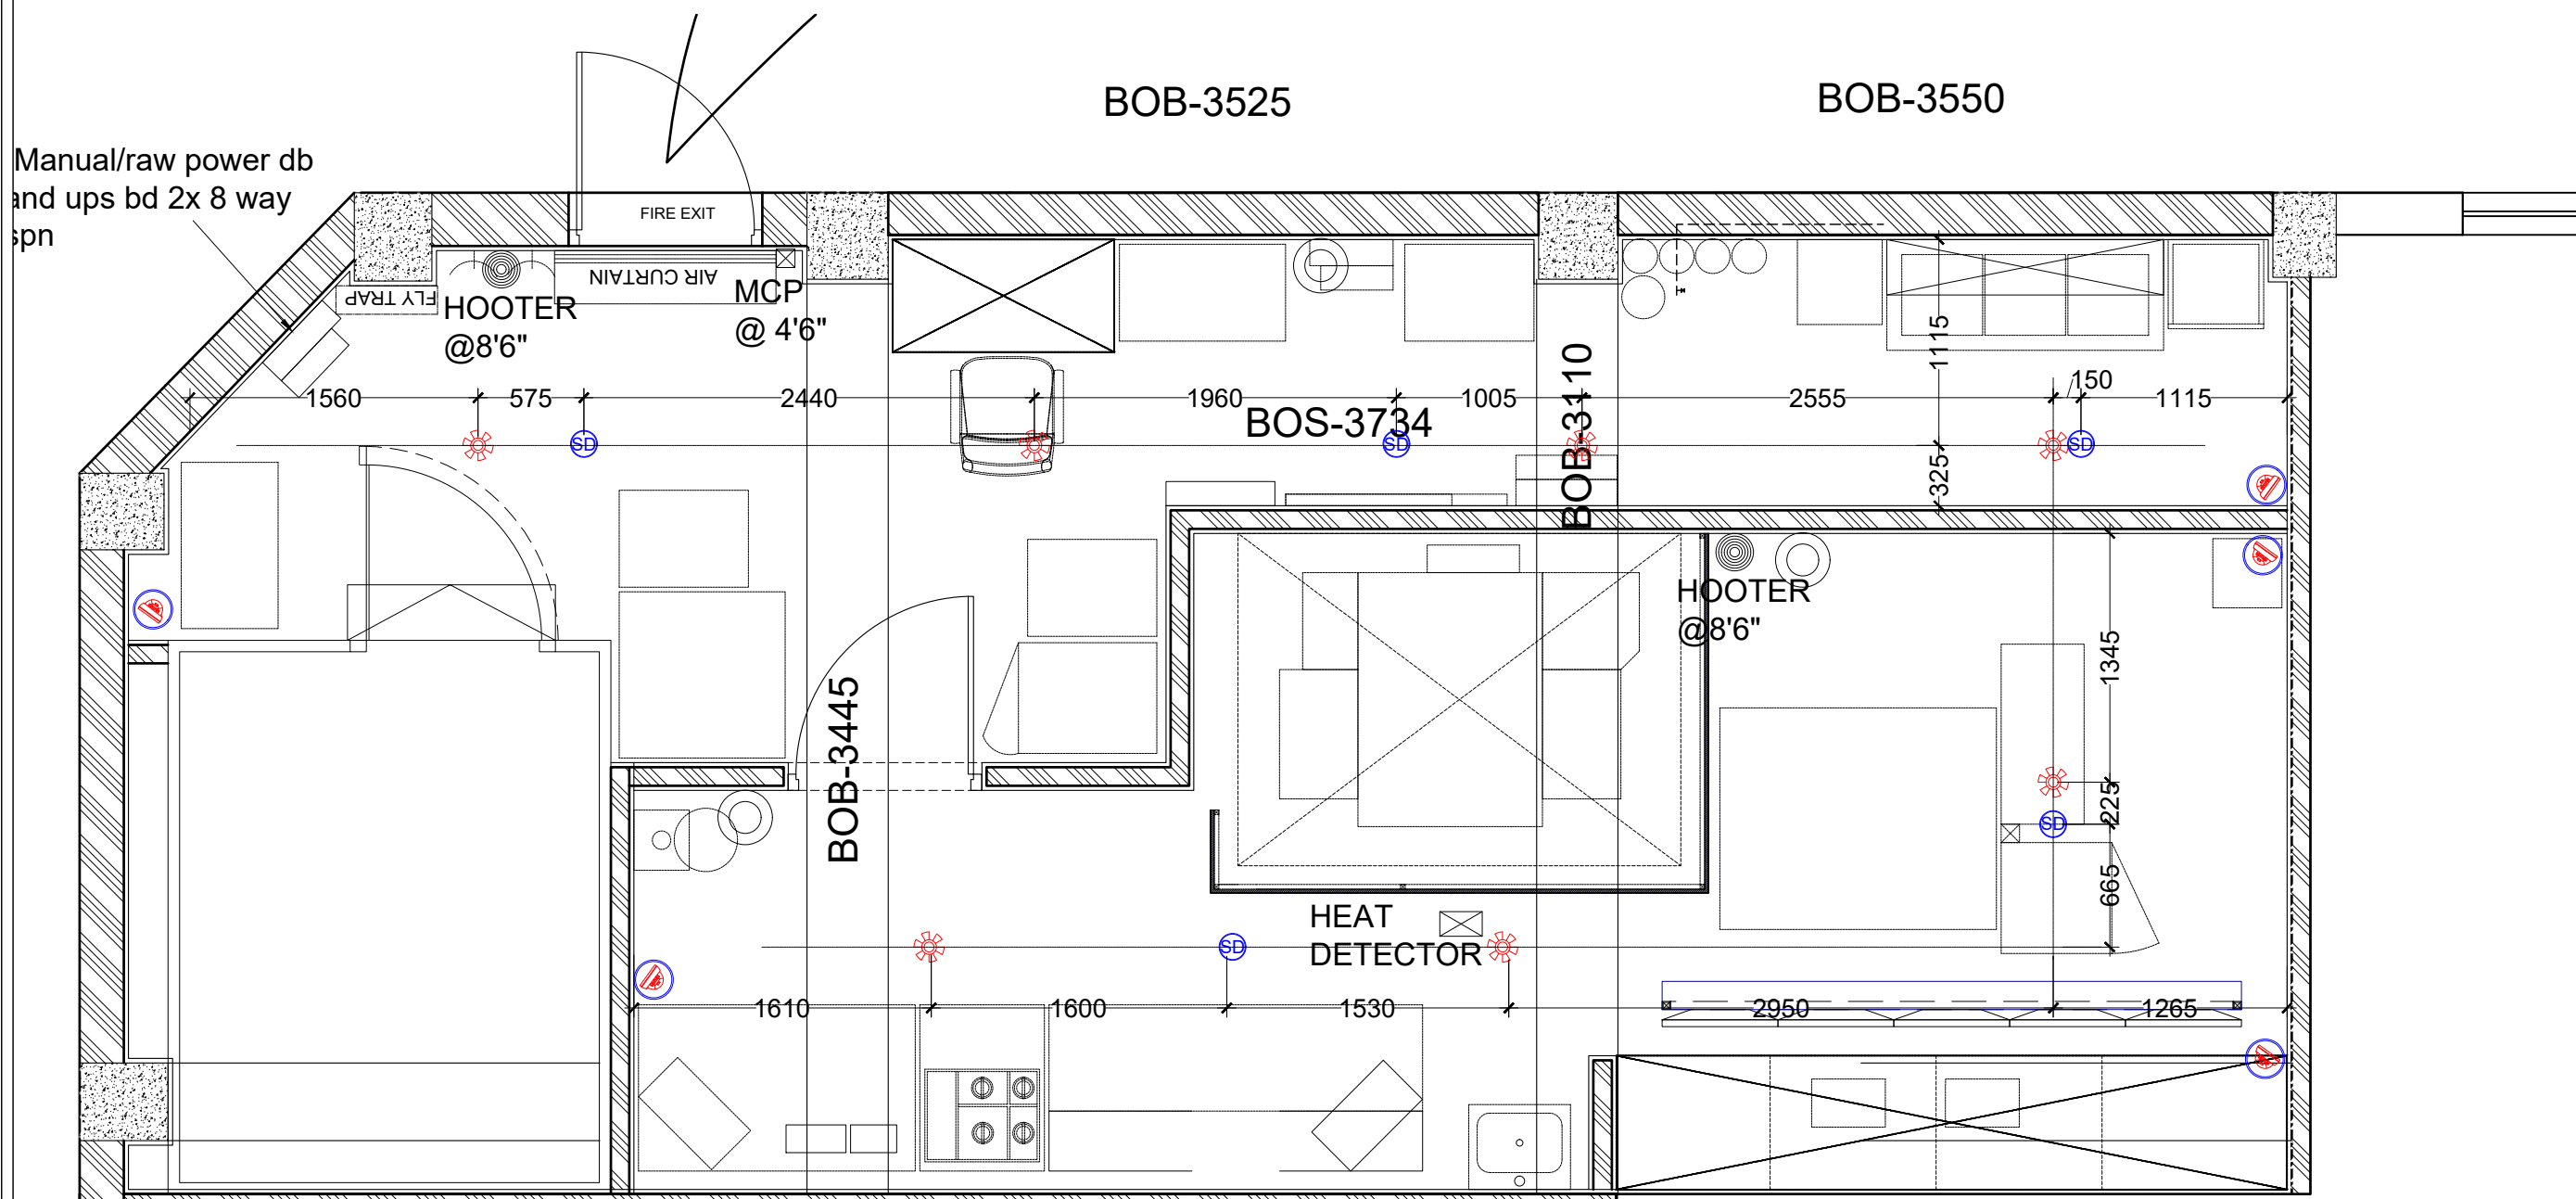

Manual/raw power db  
and ups bd 2x 8 way  
spn

BOB-3525

BOB-3550

HOOTER  
@8'6"

MCP  
@ 4'6"

BOS-3734

BOB-3410


BOB-3445

HOOTER  
@8'6"

HEAT  
DETECTOR

**LEGEND**

SYMBOL	PRODUCT- DESCRIPTION
	CCTV CAMERA
	SPRINKLER
	SMOKE DETECTOR
	FIRE EXTINGUISHER
	MCP @ 4'6"
	HOOTER @8'6"
	HEAT DETECTOR

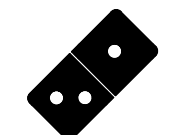

**Domino's  
Pizza**

JUBILANT FOODWORKS LTD.  
(DOMINO'S PIZZA INDIA LTD.)  
LOGIX TECHNO PARK, PLOT NO. 5,  
TOWER - D, 5th FLOOR,  
SECTOR - 127, NOIDA-201304.  
PHONE: 0120-4090500, 4090594.

THESE PLANS & SPECIFICATIONS AS WELL AS DOMINO'S  
NAME & LOGO, TRADEMARKS & DESIGNS ARE THE EXCLUSIVE  
PROPERTY OF JUBILANT COMPANY. ANY REPRODUCTION,  
MODIFICATION, DISCLOSURE AND/OR USE OF THESE  
MATERIALS (OR BY PORTION OF THEM) WITHOUT DOMINO'S  
PRIOR WRITTEN CONSENT IS STRICTLY PROHIBITED.

**DISCLAIMER-**  
IN CASE OF ANY SITE DISCREPANCY,  
PLEASE GET BACK TO CORPORATE  
DESIGN TEAM

JUBILANT FOODWORKS  
INDIA LTD.

PROJ :UNA. HIMACHAL  
:PREDESH  
ZONE : NORTH  
COUNTRY : INDIA.

RESTAURANT NO.:

TOTAL CARPET AREA : 631 SQ.FT.  
CUSTOMER AREA : SQ.FT.  
KITCHEN AREA : 405 SQ.FT.  
BOH AREA : 236 SQ.FT.  
NO. OF COVERS :  
BOTTOM OF SLAB : 3734  
BOTTOM OF BEAM : 3110 & 3445  
SHUTTER OPENING HT. :---

DRAWN BY : VARUN

CHECKED BY :

ISSUED ON : 22-01-2024


REVISION NO.	REVISION DATE
1	-2022
2	-2022
3	-2022
4	-2022


REMARKS :

SCALE : NOT TO SCALE.


SHEET NO. : 10

SHEET TITLE : SD,SMK,CAMERA & FIRE  
PLAN

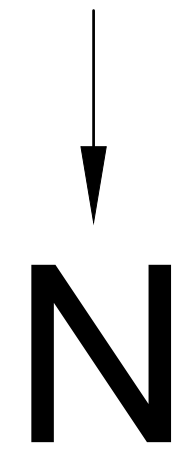

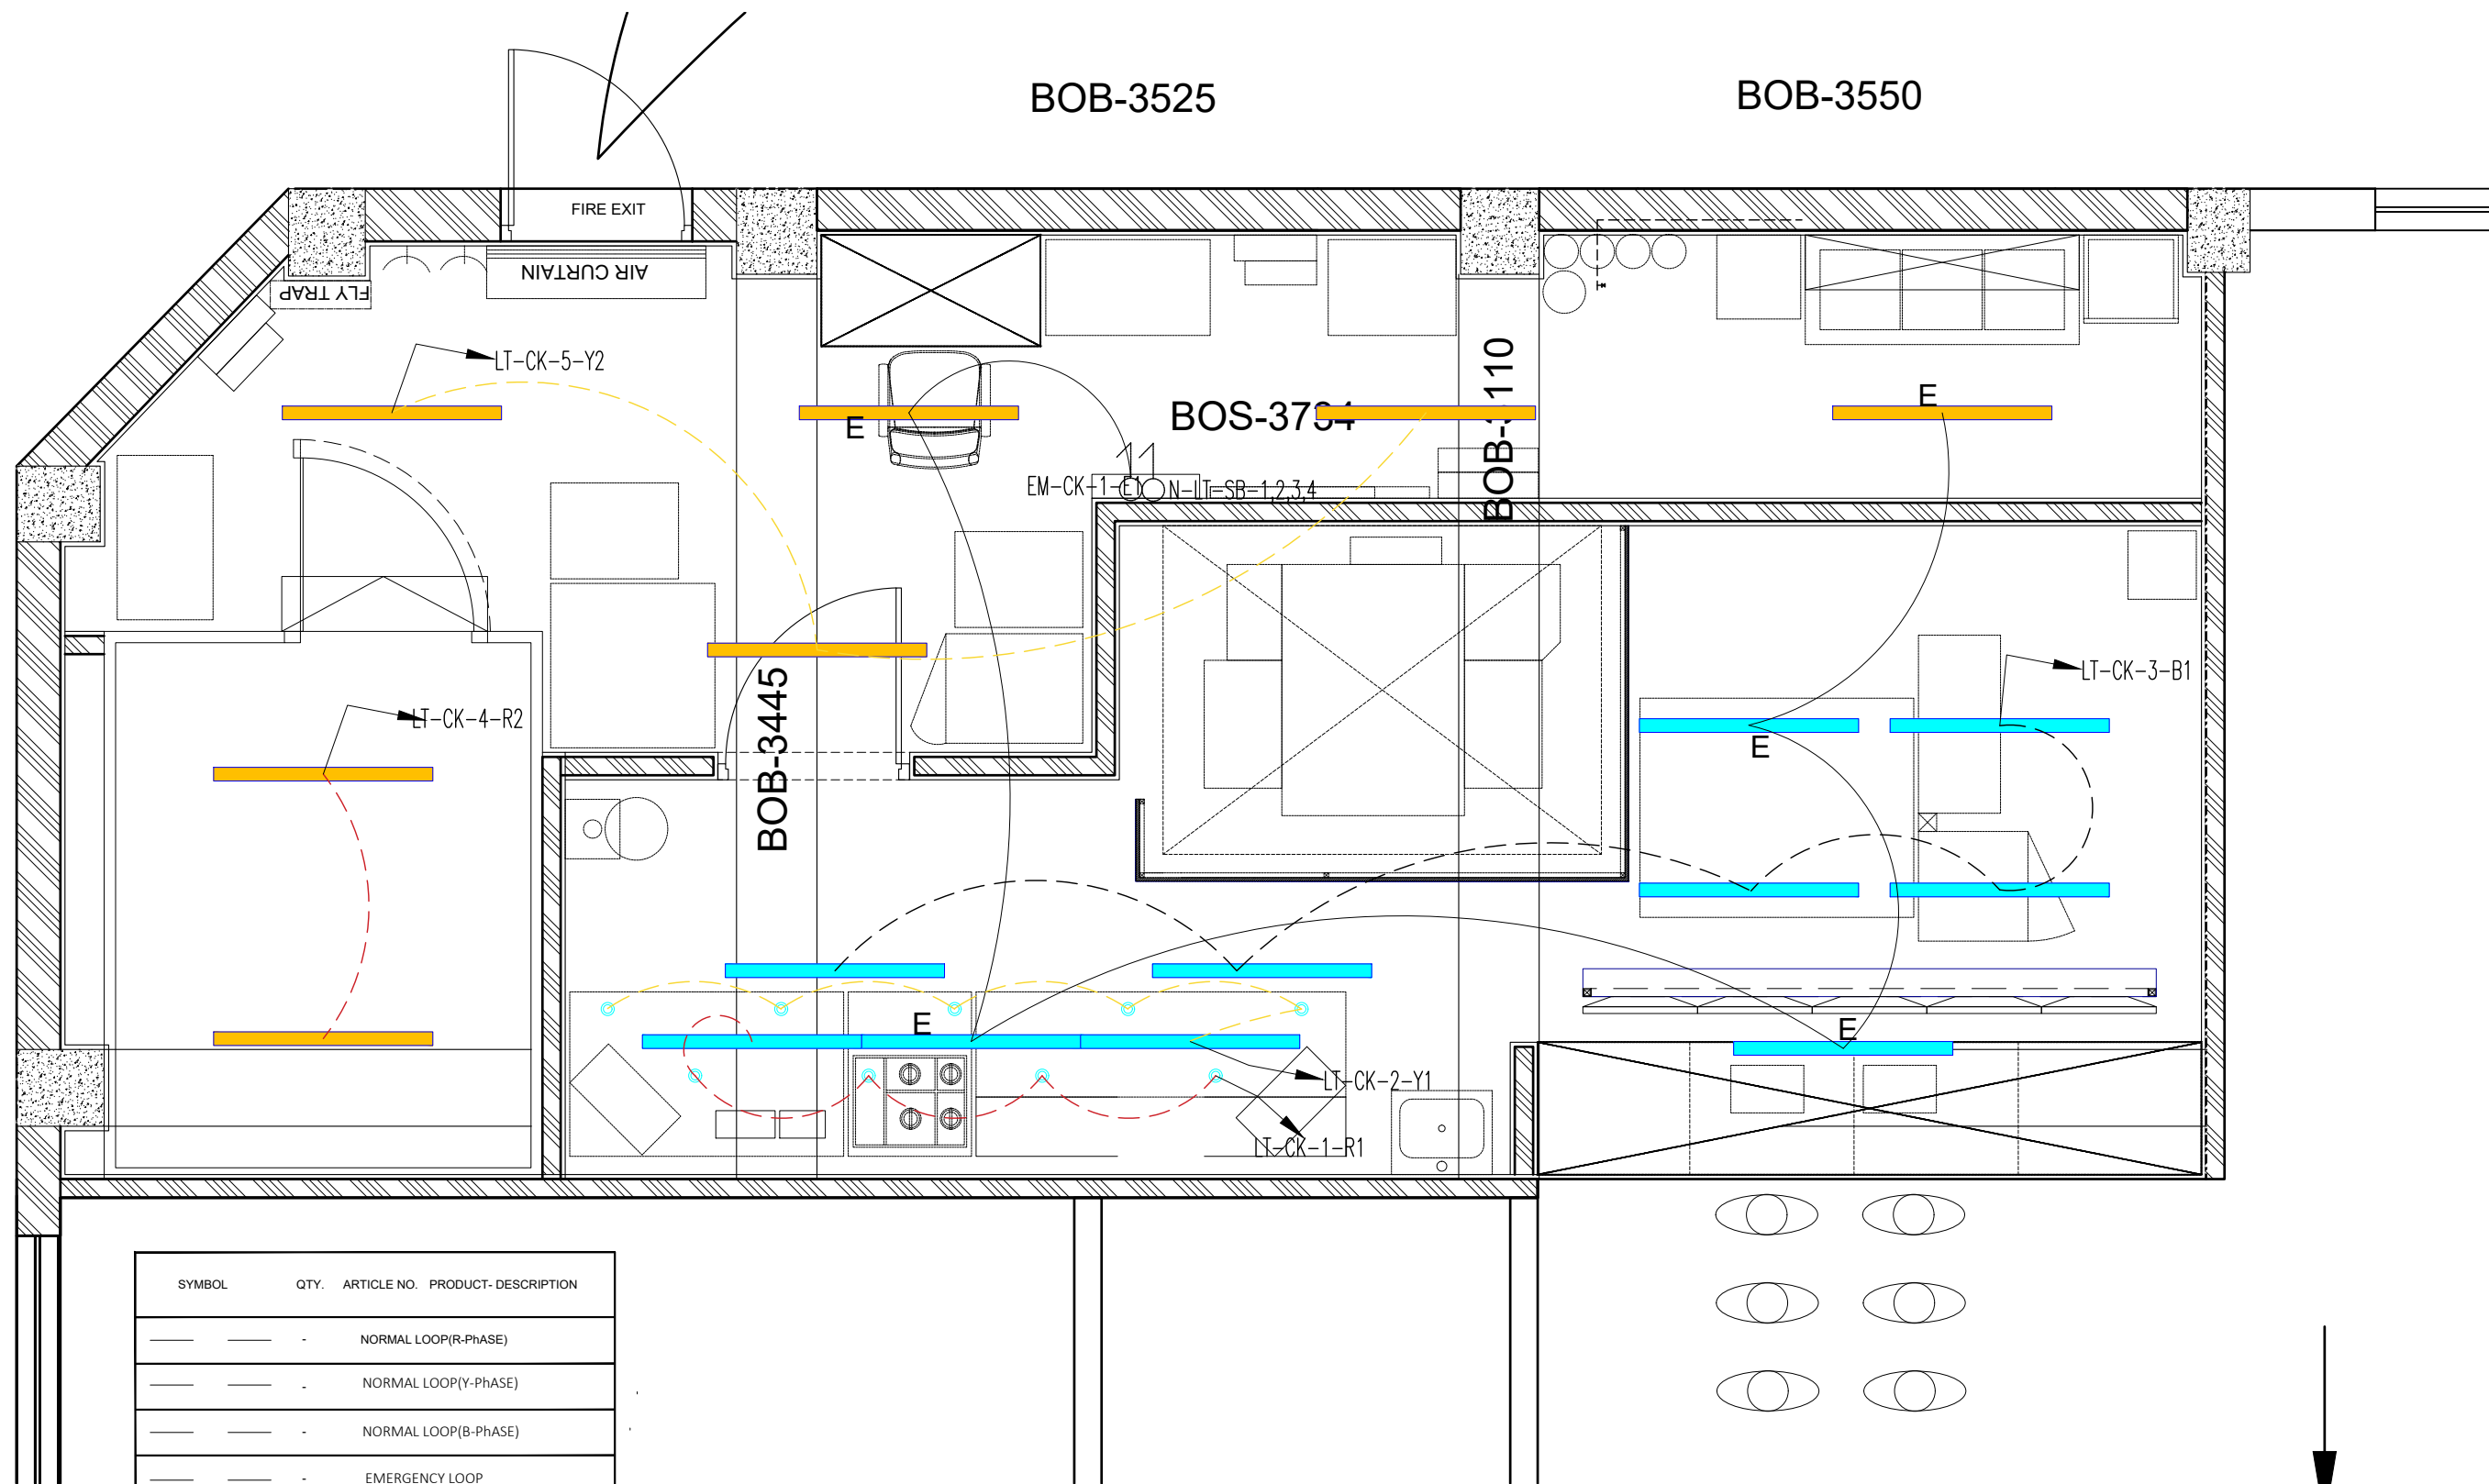

SYMBOL	QTY.	ARTICLE NO.	PRODUCT- DESCRIPTION
---	---	-	NORMAL LOOP(R-PHASE)
---	---	-	NORMAL LOOP(Y-PHASE)
---	---	-	NORMAL LOOP(B-PHASE)
---	---	-	EMERGENCY LOOP
⌋○	-	-	SWITCH BOARD NORMAL LIGHT
⌋○	-	-	SWITCH BOARD EMERGENCY LIGHT

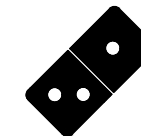

**Domino's  
Pizza**

JUBILANT FOODWORKS LTD.  
(DOMINO'S PIZZA INDIA LTD.)  
LOGIX TECHNO PARK, PLOT NO. 5,  
TOWER - D, 5th FLOOR,  
SECTOR - 127, NOIDA-201304.  
PHONE: 0120-4090500, 4090594.

THESE PLANS & SPECIFICATIONS AS WELL AS DOMINO'S  
NAME & LOGO, TRADEMARKS & DESIGNS ARE THE EXCLUSIVE  
PROPERTY OF JUBILANT COMPANY. ANY REPRODUCTION,  
MODIFICATION, DISCLOSURE AND/OR USE OF THESE  
MATERIALS (OR BY PORTION OF THEM) WITHOUT DOMINO'S  
PRIOR WRITTEN CONSENT IS STRICTLY PROHIBITED.

**DISCLAIMER-**  
IN CASE OF ANY SITE DISCREPANCY,  
PLEASE GET BACK TO CORPORATE  
DESIGN TEAM

JUBILANT FOODWORKS  
INDIA LTD.

PROJ :UNA. HIMACHAL  
:PREDESH  
ZONE : NORTH  
COUNTRY : INDIA.

RESTAURANT NO.:


TOTAL CARPET AREA : 631 SQ.FT.  
CUSTOMER AREA : SQ.FT.  
KITCHEN AREA : 405 SQ.FT.  
BOH AREA : 236 SQ.FT.  
NO. OF COVERS :  
BOTTOM OF SLAB : 3734  
BOTTOM OF BEAM : 3110 & 3445  
SHUTTER OPENING HT.:


DRAWN BY : VARUN  
CHECKED BY :

ISSUED ON : 22-01-2024

REVISION NO.	REVISION DATE
1	-2022
2	-2022
3	-2022
4	-2022

REMARKS :  
SCALE : NOT TO SCALE.  
SHEET NO. : 11  
SHEET TITLE : LOOKING PLAN

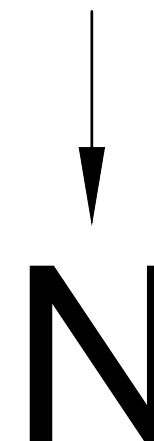

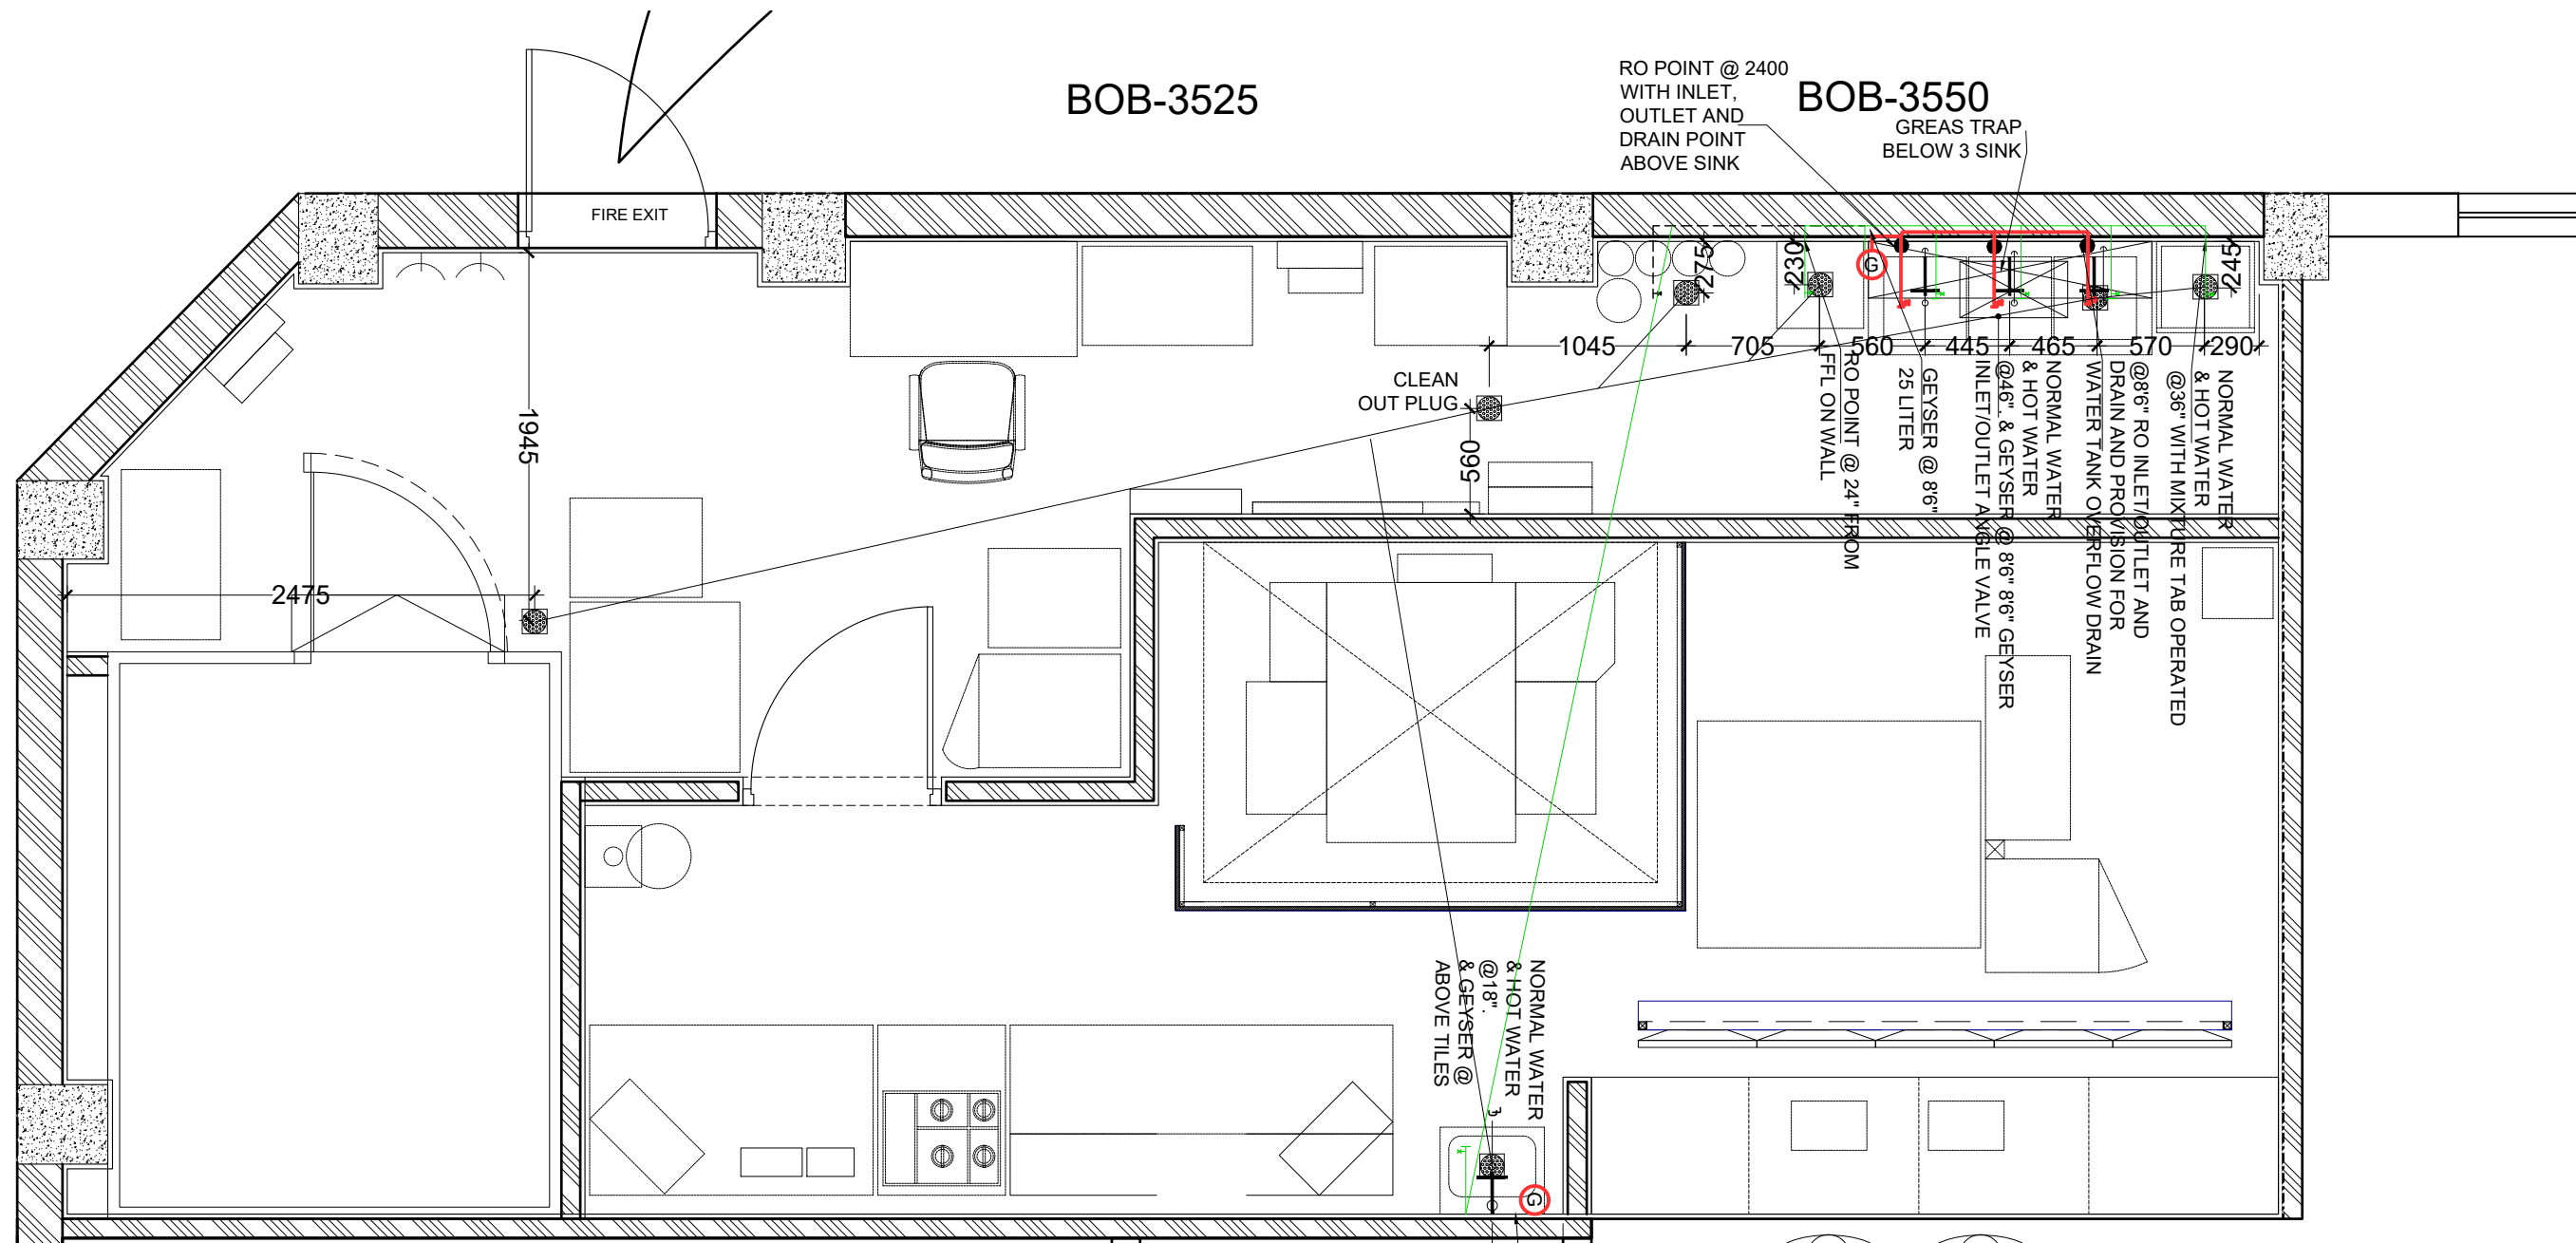

BOB-3525

RO POINT @ 2400 WITH INLET, OUTLET AND DRAIN POINT ABOVE SINK

BOB-3550 GREAS TRAP BELOW 3 SINK

FIRE EXIT


CLEAN OUT PLUG

NORMAL WATER & HOT WATER @ 18" & GEYSER @ 86" ABOVE TILES

GEYSER 3 OR 5LITER USED CONCEALED COCK FOR HOT AND COLD CONTROL. GEYSER INLET/OUTLET ANGLE VALVE @ 7' HT

PLUMBING LEGEND:		
Sr.	DESCRIPTION	SYMBOL
1.	SEWERAGE DRAIN LINE	
2.	WASTE WATER DRAIN LINE	
3.	DOMESTIC WATER LINE	
4.	HOT WATER LINE	
5.	GEYSER	
6.	ANGULAR COCK	
7.	BALL VALVE (@ INCOMING CEILING LEVEL)	
8.	R.O WATER LINE	

Note:-BOTTLE TRAP TO BE PROVIDED AT MAKELINE SINK AND HAND WASH & IN WASHROOM. EVERY DROP LINE MUST HAVE BALLVALVE. RO POINT @2400MM (INLET, OUTLET AND DRAIN)

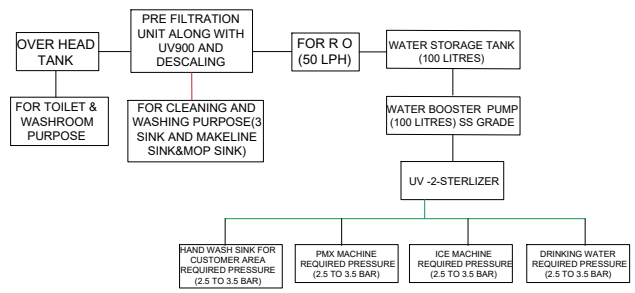

**Domino's Pizza**

JUBILANT FOODWORKS LTD.  
(DOMINO'S PIZZA INDIA LTD.)  
LOGIX TECHNO PARK, PLOT NO. 5,  
TOWER - D, 5th FLOOR,  
SECTOR - 127, NOIDA-201304.  
PHONE: 0120-4090500, 4090594.

THESE PLANS & SPECIFICATIONS AS WELL AS DOMINO'S NAME & LOGO, TRADEMARKS & DESIGNS ARE THE EXCLUSIVE PROPERTY OF JUBILANT COMPANY. ANY REPRODUCTION, MODIFICATION, DISCLOSURE AND/OR USE OF THESE MATERIALS (OR BY PORTION OF THEM) WITHOUT DOMINO'S PRIOR WRITTEN CONSENT IS STRICTLY PROHIBITED.

**DISCLAIMER-**  
IN CASE OF ANY SITE DISCREPANCY, PLEASE GET BACK TO CORPORATE DESIGN TEAM

JUBILANT FOODWORKS INDIA LTD.

PROJ :UNA. HIMACHAL  
ZONE :PREDESH  
COUNTRY :INDIA.


RESTAURANT NO.: .

TOTAL CARPET AREA : 631 SQ.FT.  
CUSTOMER AREA : SQ.FT.  
KITCHEN AREA : 405 SQ.FT.  
BOH AREA : 236 SQ.FT.  
NO. OF COVERS :  
BOTTOM OF SLAB : 3734  
BOTTOM OF BEAM : 3110 & 3445  
SHUTTER OPENING HT.:----

DRAWN BY : VARUN  
CHECKED BY :  
ISSUED ON : 22-01-2024

REVISION NO.	REVISION DATE
1	-2022
2	-2022
3	-2022
4	-2022

REMARKS :  
SCALE : NOT TO SCALE.  
SHEET NO. : 12  
SHEET TITLE : PLUMBING PLAN

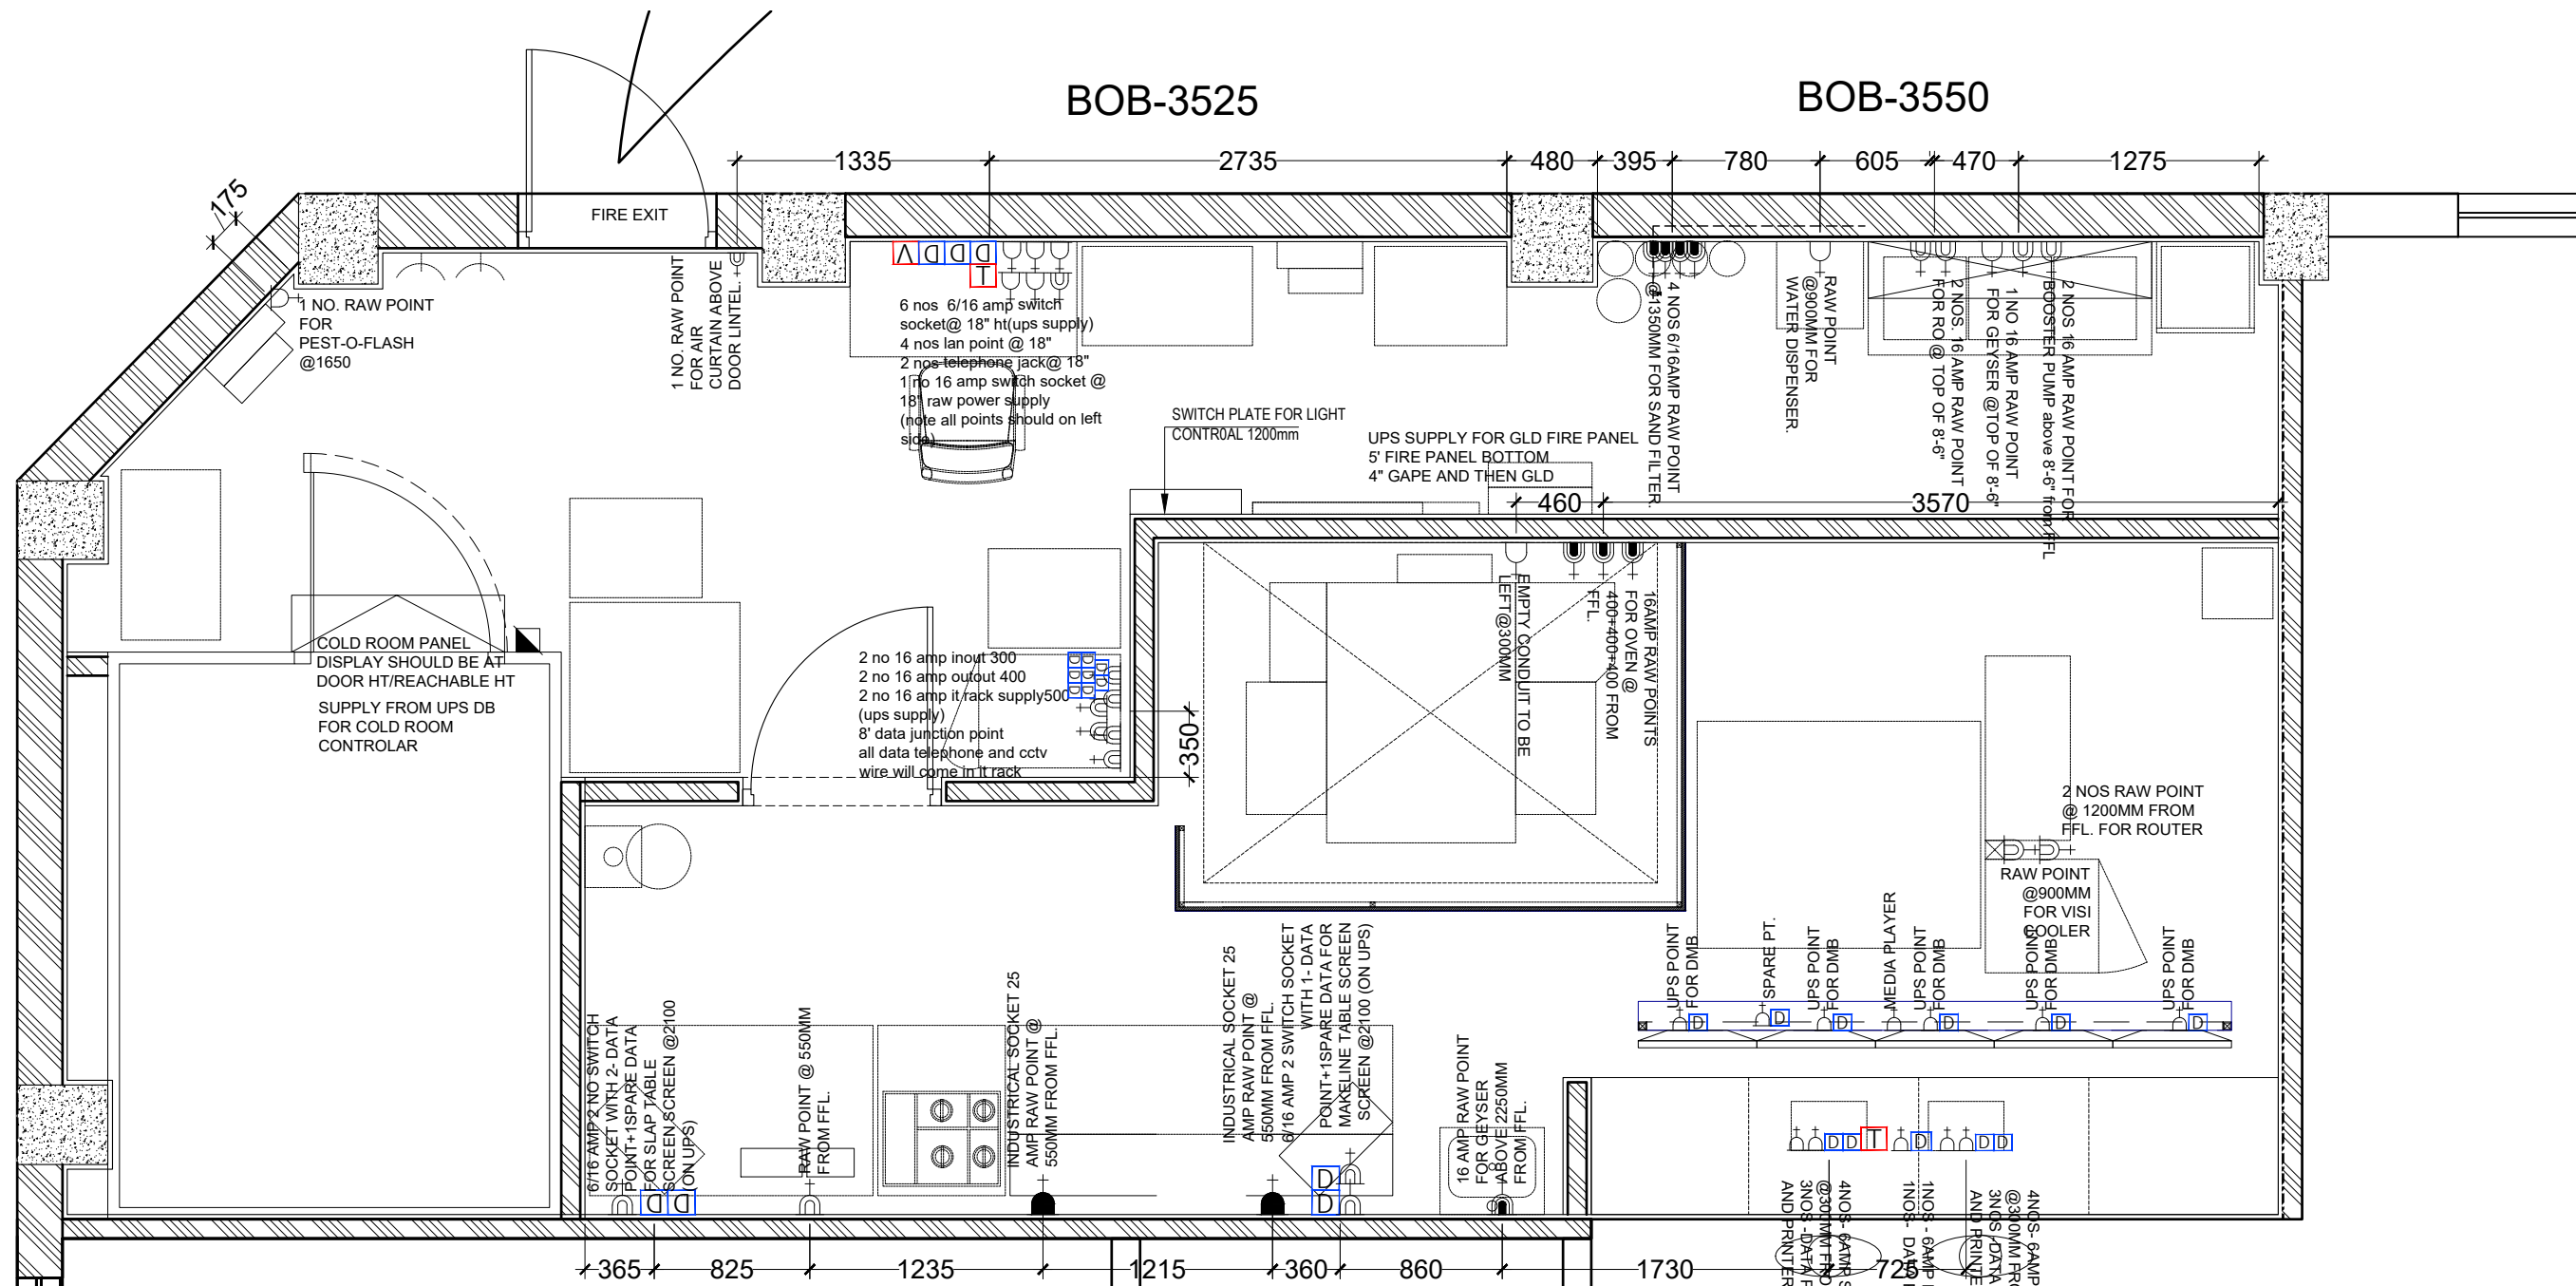

LEGEND - POWER	
SYMBOL	DESCRIPTION
	6A SOCKET WITH SWITCH
	16A SOCKET WITH SWITCH
	6/16A SOCKET WITH SWITCH
	25A SWITCH & SOCKET (230V, 1 PH, A.C. SUPPLY)
	DATA POINT
	VOICE POINT.
	TELEPHONE

**NOTE FOR AC :**  
 Hi wall Ac - 25 amp DP MCB (Raw)  
 wheater proof box near outdoor unit

3 Ton Cassette Ac - 4 Pole 32 amp  
 for 3 phase ac-Raw  
 wheater proof box near outdoor unit

2 Ton Cassette Ac -2 Pole 25 amp  
 for 1 phase ac -Raw  
 wheater proof box near outdoor unit

**Domino's Pizza**

JUBILANT FOODWORKS LTD.  
 (DOMINO'S PIZZA INDIA LTD.)  
 LOGIX TECHNO PARK, PLOT NO. 5,  
 TOWER - D, 5th FLOOR,  
 SECTOR - 127, NOIDA-201304.  
 PHONE: 0120-4090500, 4090594.

THESE PLANS & SPECIFICATIONS AS WELL AS DOMINO'S NAME & LOGO, TRADEMARKS & DESIGNS ARE THE EXCLUSIVE PROPERTY OF JUBILANT COMPANY. ANY REPRODUCTION, MODIFICATION, DISCLOSURE AND/OR USE OF THESE MATERIALS (OR BY PORTION OF THEM) WITHOUT DOMINO'S PRIOR WRITTEN CONSENT IS STRICTLY PROHIBITED.

**DISCLAIMER-**  
 IN CASE OF ANY SITE DISCREPANCY,  
 PLEASE GET BACK TO CORPORATE  
 DESIGN TEAM

JUBILANT FOODWORKS  
 INDIA LTD.

PROJ :UNA. HIMACHAL  
 ZONE : PREDESH  
 COUNTRY : INDIA.


RESTAURANT NO. : .


TOTAL CARPET AREA : 631 SQ.FT.  
 CUSTOMER AREA : SQ.FT.  
 KITCHEN AREA : 405 SQ.FT.  
 BOH AREA : 236 SQ.FT.  
 NO. OF COVERS :  
 BOTTOM OF SLAB : 3734  
 BOTTOM OF BEAM : 3110 & 3445  
 SHUTTER OPENING HT. : ----

DRAWN BY : VARUN  
 CHECKED BY :  
 ISSUED ON : 22-01-2024

REVISION NO.	REVISION DATE
1	-2022
2	-2022
3	-2022
4	-2022

REMARKS :  
 SCALE : NOT TO SCALE.  
 SHEET NO. : 13  
 SHEET TITLE : ELECTRICAL PLAN

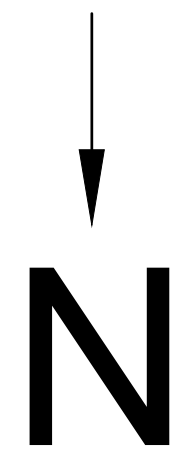

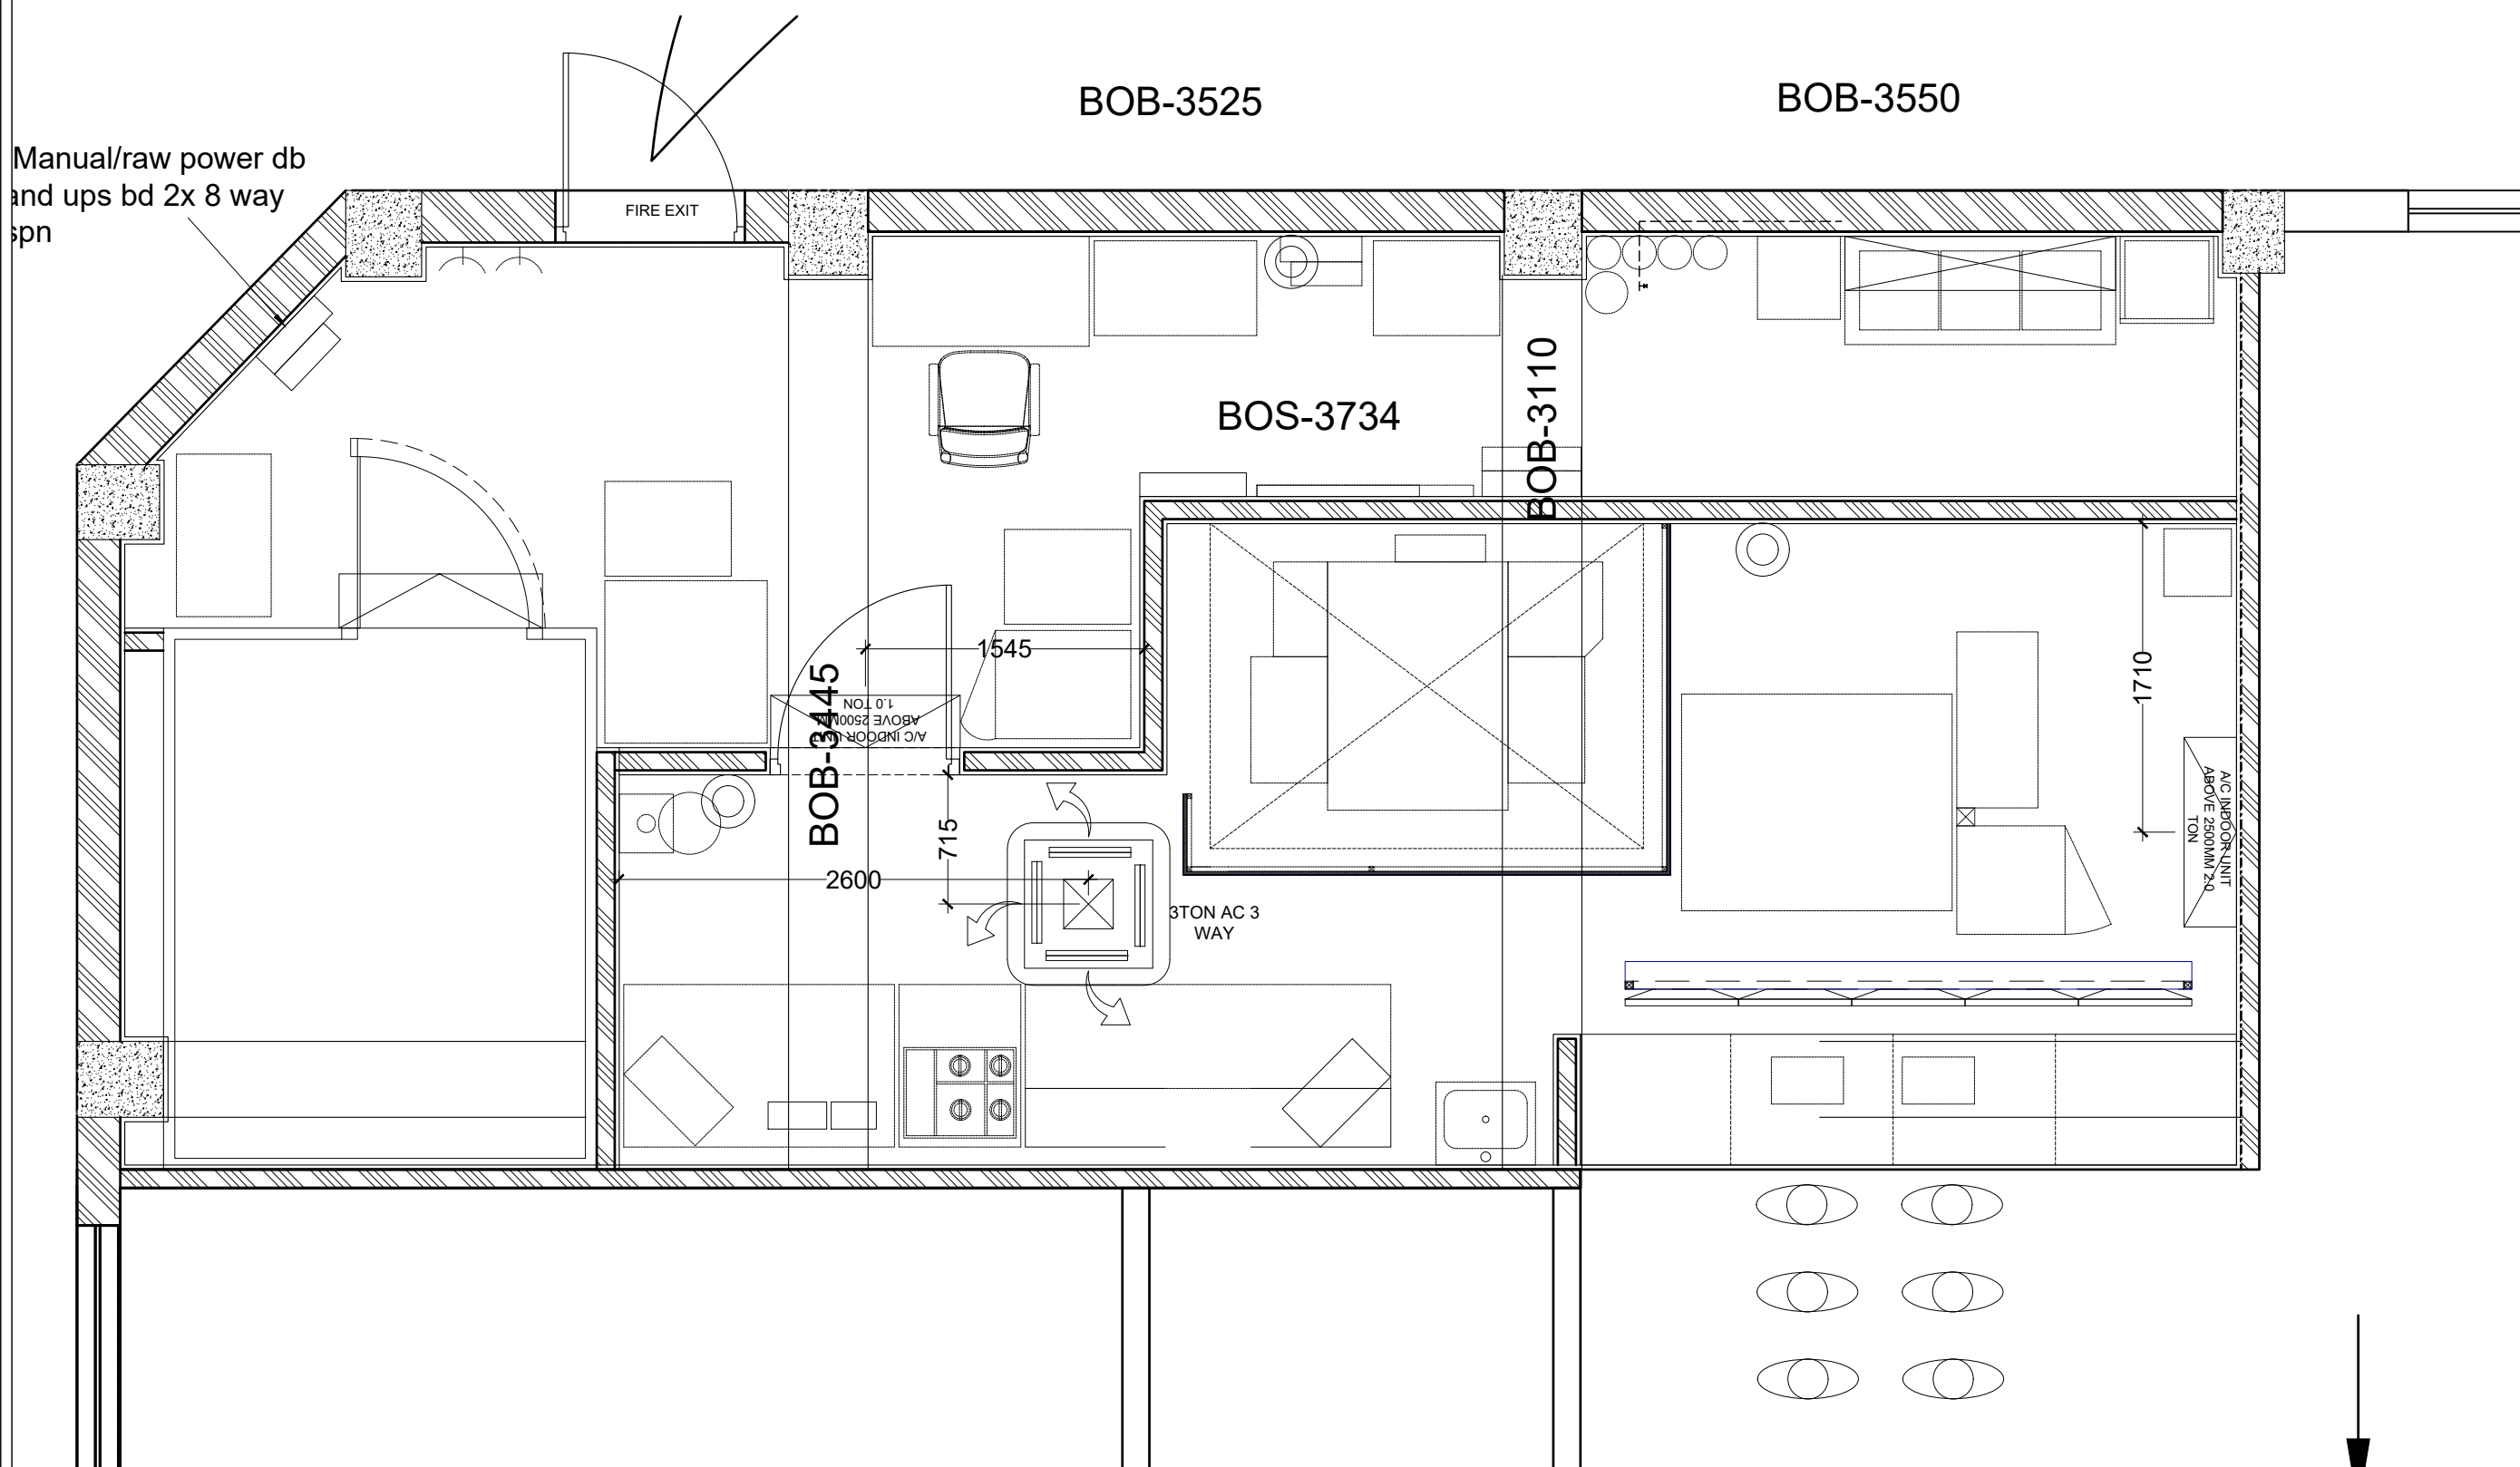

Manual/raw power db  
and ups bd 2x 8 way  
spn

FIRE EXIT

BOB-3525

BOB-3550

BOS-3734

BOB-3110

BOB-3445

A/C INDOOR UNIT  
ABOVE 2500MM  
1.0 TON

1545

715


2600

3TON AC 3  
WAY

1710

A/C INDOOR UNIT  
ABOVE 2500MM 2.0  
TON

HVAC LEGEND				
SYMBOL	DESCRIPTION	TON	NO.	AREA
	SPLIT AC (ABOVE 2500MM)	1 TON	1	BOH.
	SPLIT AC (ABOVE 2500MM)	1 TON	2	KITCHEN
	3-WAY CASSETTE UNIT	3 TON	1	KITCHEN

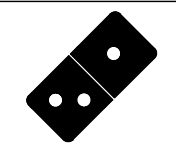

Domino's  
Pizza

JUBILANT FOODWORKS LTD.  
(DOMINO'S PIZZA INDIA LTD.)  
LOGIX TECHNO PARK, PLOT NO. 5,  
TOWER - D, 5th FLOOR,  
SECTOR - 127, NOIDA-201304.  
PHONE: 0120-4090500, 4090594.

THESE PLANS & SPECIFICATIONS AS WELL AS DOMINO'S  
NAME & LOGO, TRADEMARKS & DESIGNS ARE THE EXCLUSIVE  
PROPERTY OF JUBILANT COMPANY. ANY REPRODUCTION,  
MODIFICATION, DISCLOSURE AND/OR USE OF THESE  
MATERIALS (OR BY PORTION OF THEM) WITHOUT DOMINO'S  
PRIOR WRITTEN CONSENT IS STRICTLY PROHIBITED.

DISCLAIMER-  
IN CASE OF ANY SITE DISCREPANCY,  
PLEASE GET BACK TO CORPORATE  
DESIGN TEAM

JUBILANT FOODWORKS  
INDIA LTD.

PROJ :UNA. HIMACHAL  
:PREDESH  
ZONE : NORTH  
COUNTRY : INDIA.

RESTAURANT NO.: .

TOTAL CARPET AREA : 631 SQ.FT.  
CUSTOMER AREA : SQ.FT.  
KITCHEN AREA : 405 SQ.FT.  
BOH AREA : 236 SQ.FT.  
NO. OF COVERS :  
BOTTOM OF SLAB : 3734  
BOTTOM OF BEAM : 3110 & 3445  
SHUTTER OPENING HT.:----

DRAWN BY : VARUN

CHECKED BY :

ISSUED ON : 22-01-2024


REVISION NO.	REVISION DATE
1	-2022
2	-2022
3	-2022
4	-2022





REMARKS :

SCALE : NOT TO SCALE.

SHEET NO. : 14

SHEET TITLE : AC PLAN

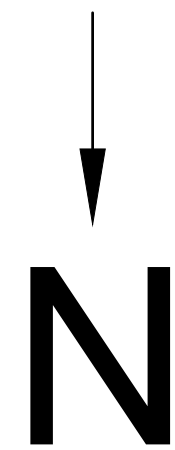

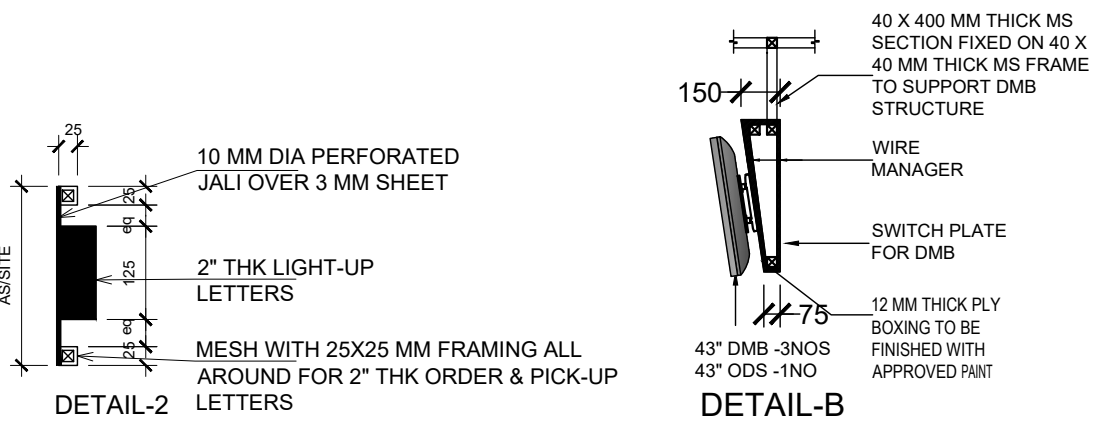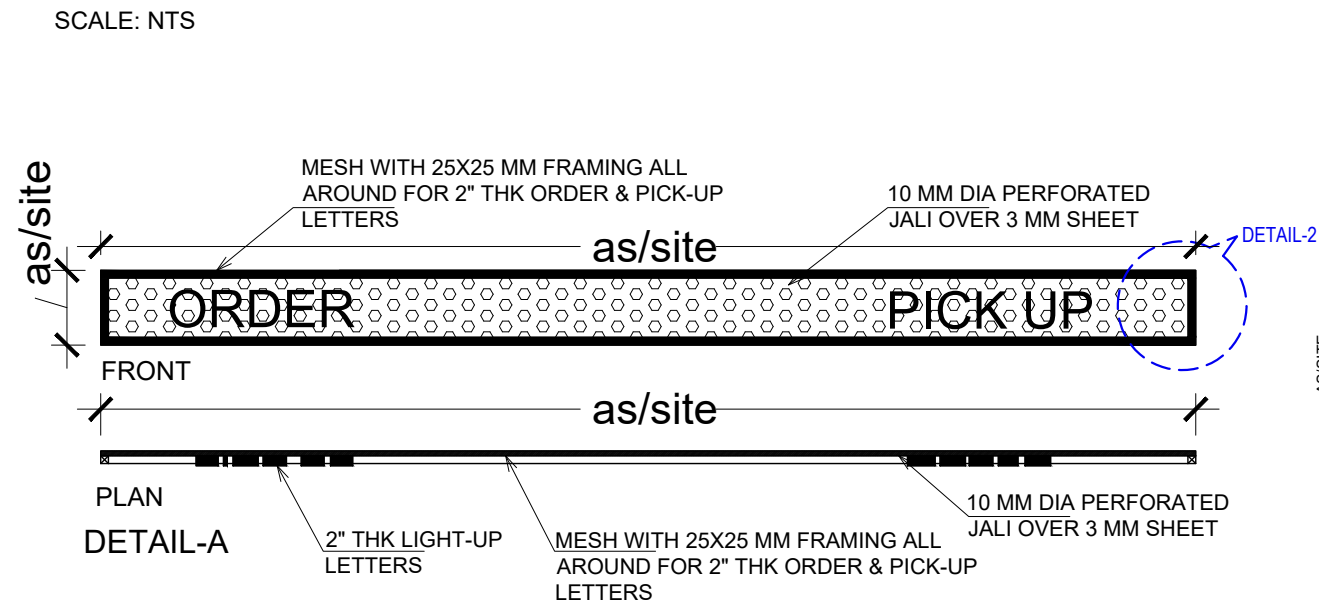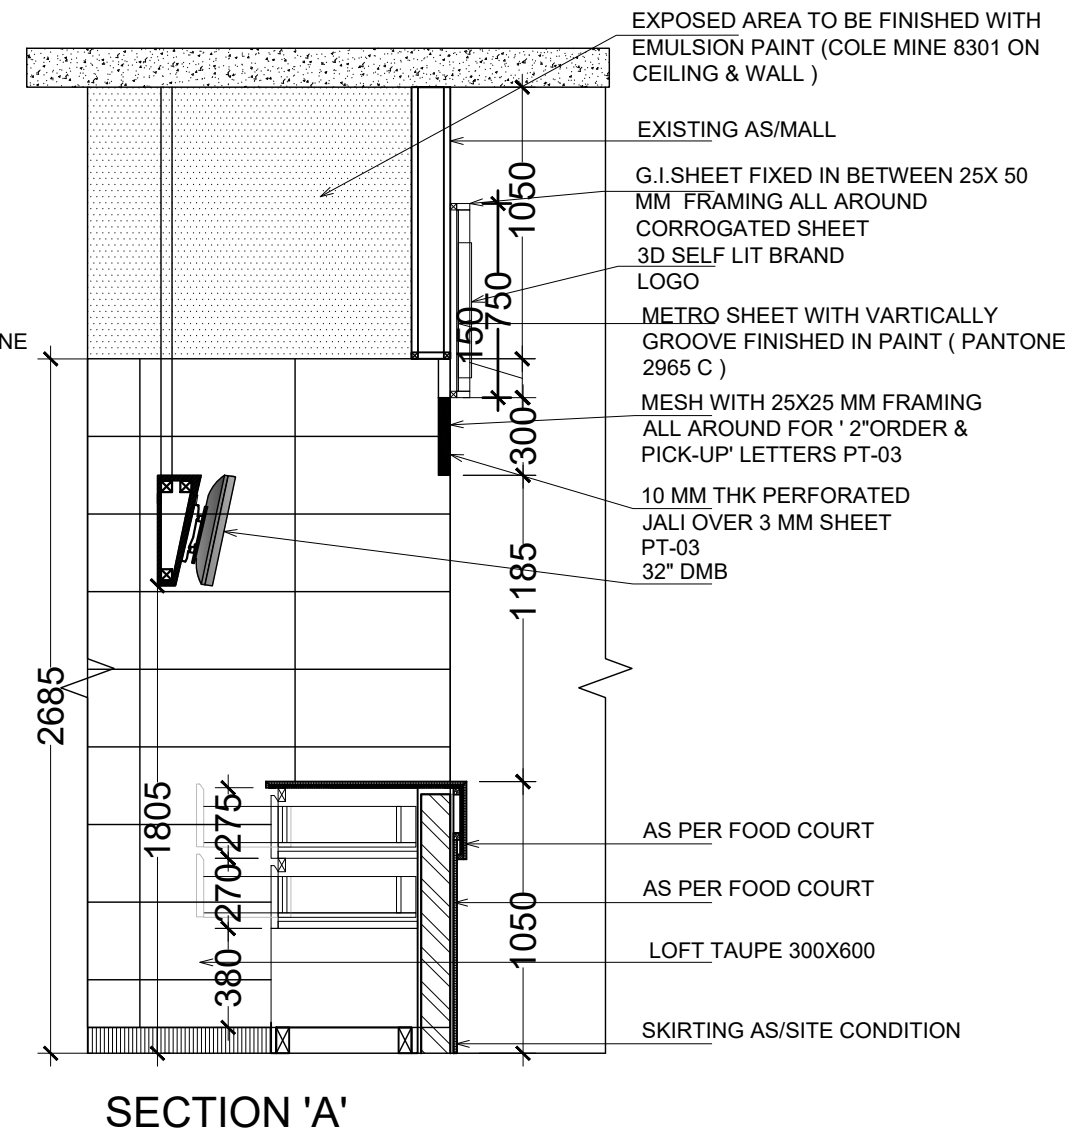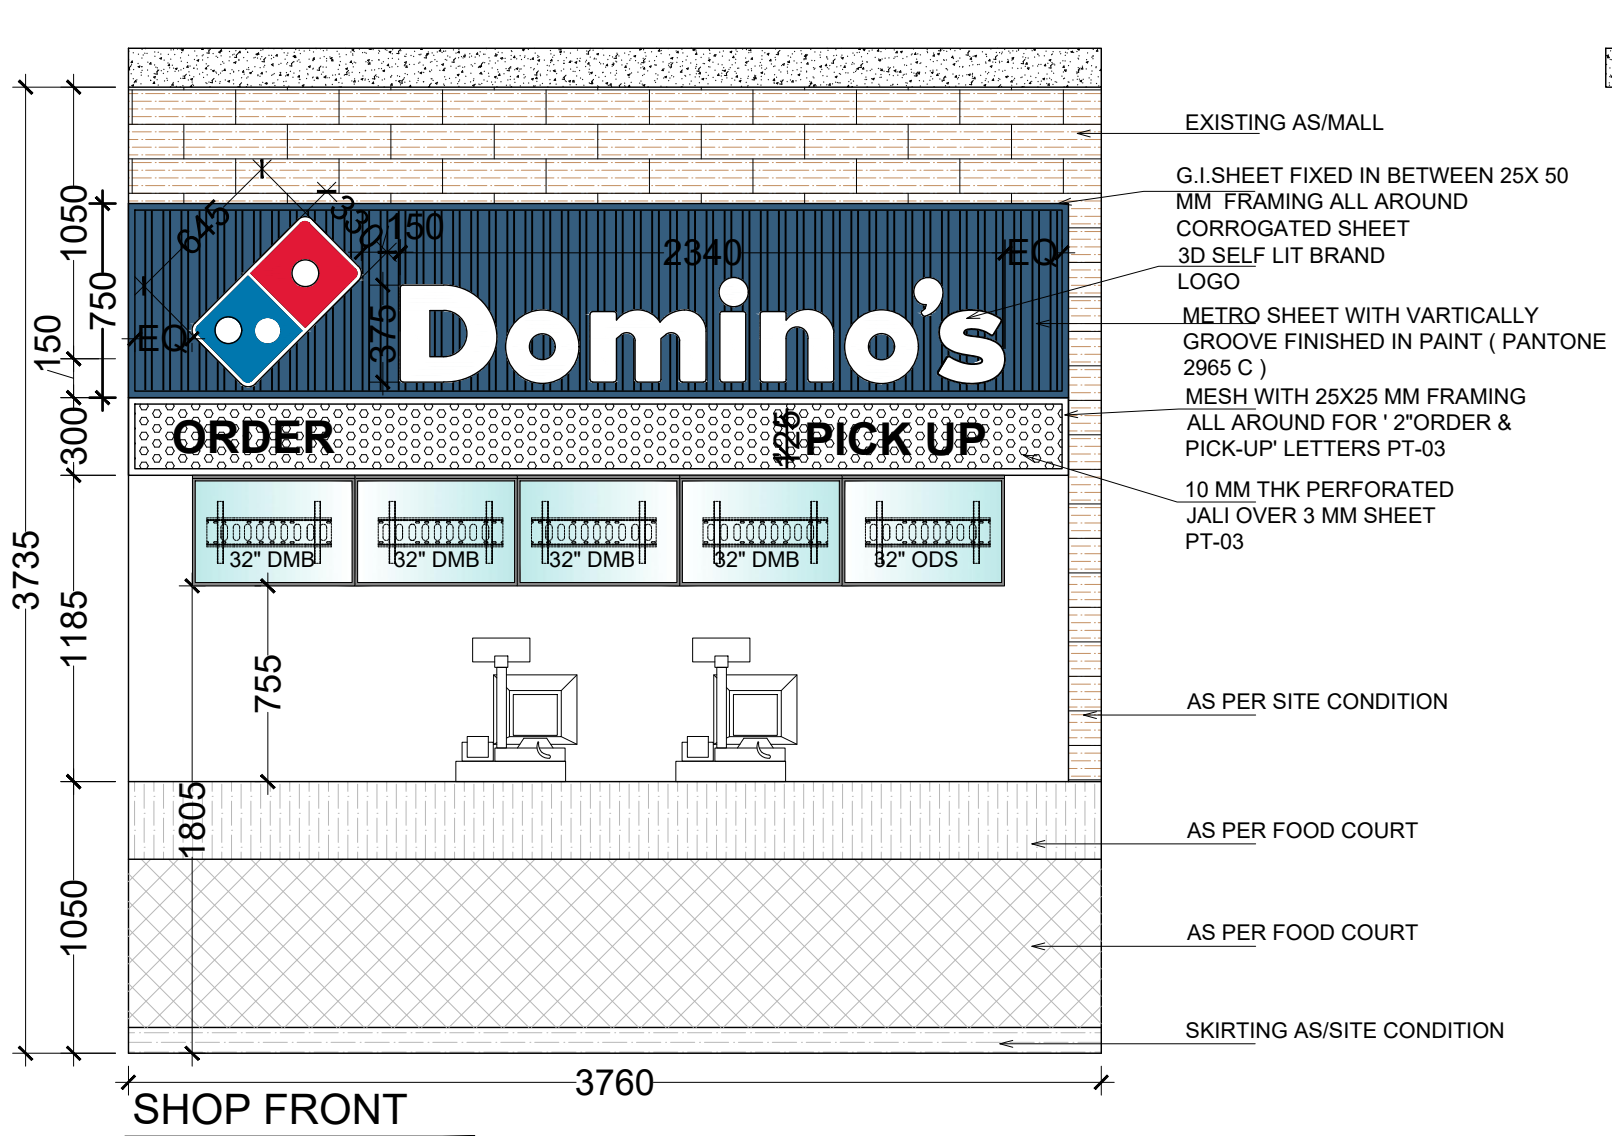

**Domino's Pizza**

JUBILANT FOODWORKS LTD.  
(DOMINO'S PIZZA INDIA LTD.)  
LOGIX TECHNO PARK, PLOT NO. 5,  
TOWER - D, 5th FLOOR,  
SECTOR - 127, NOIDA-201304.  
PHONE: 0120-4090500, 4090594.

THESE PLANS & SPECIFICATIONS AS WELL AS DOMINO'S NAME & LOGO, TRADEMARKS & DESIGNS ARE THE EXCLUSIVE PROPERTY OF JUBILANT COMPANY. ANY REPRODUCTION, MODIFICATION, DISCLOSURE AND/OR USE OF THESE MATERIALS (OR BY PORTION OF THEM) WITHOUT DOMINO'S PRIOR WRITTEN CONSENT IS STRICTLY PROHIBITED.

**DISCLAIMER-**  
IN CASE OF ANY SITE DISCREPANCY, PLEASE GET BACK TO CORPORATE DESIGN TEAM

JUBILANT FOODWORKS INDIA LTD.

PROJ :UNA. HIMACHAL  
ZONE :PREDESH  
COUNTRY :INDIA.

RESTAURANT NO.:..

TOTAL CARPET AREA : 631 SQ.FT.  
CUSTOMER AREA : SQ.FT.  
KITCHEN AREA : 405 SQ.FT.  
BOH AREA : 236 SQ.FT.  
NO. OF COVERS :  
BOTTOM OF SLAB : 3734  
BOTTOM OF BEAM : 3110 & 3445  
SHUTTER OPENING HT.:----

DRAWN BY : VARUN	
CHECKED BY :	
ISSUED ON : 22-01-2024	
REVISION NO.	REVISION DATE
1	-2022
2	-2022
3	-2022
4	-2022
REMARKS :	
SCALE : NOT TO SCALE.	
SHEET NO. : 15	
SHEET TITLE : ELEVATION & SECTION	