


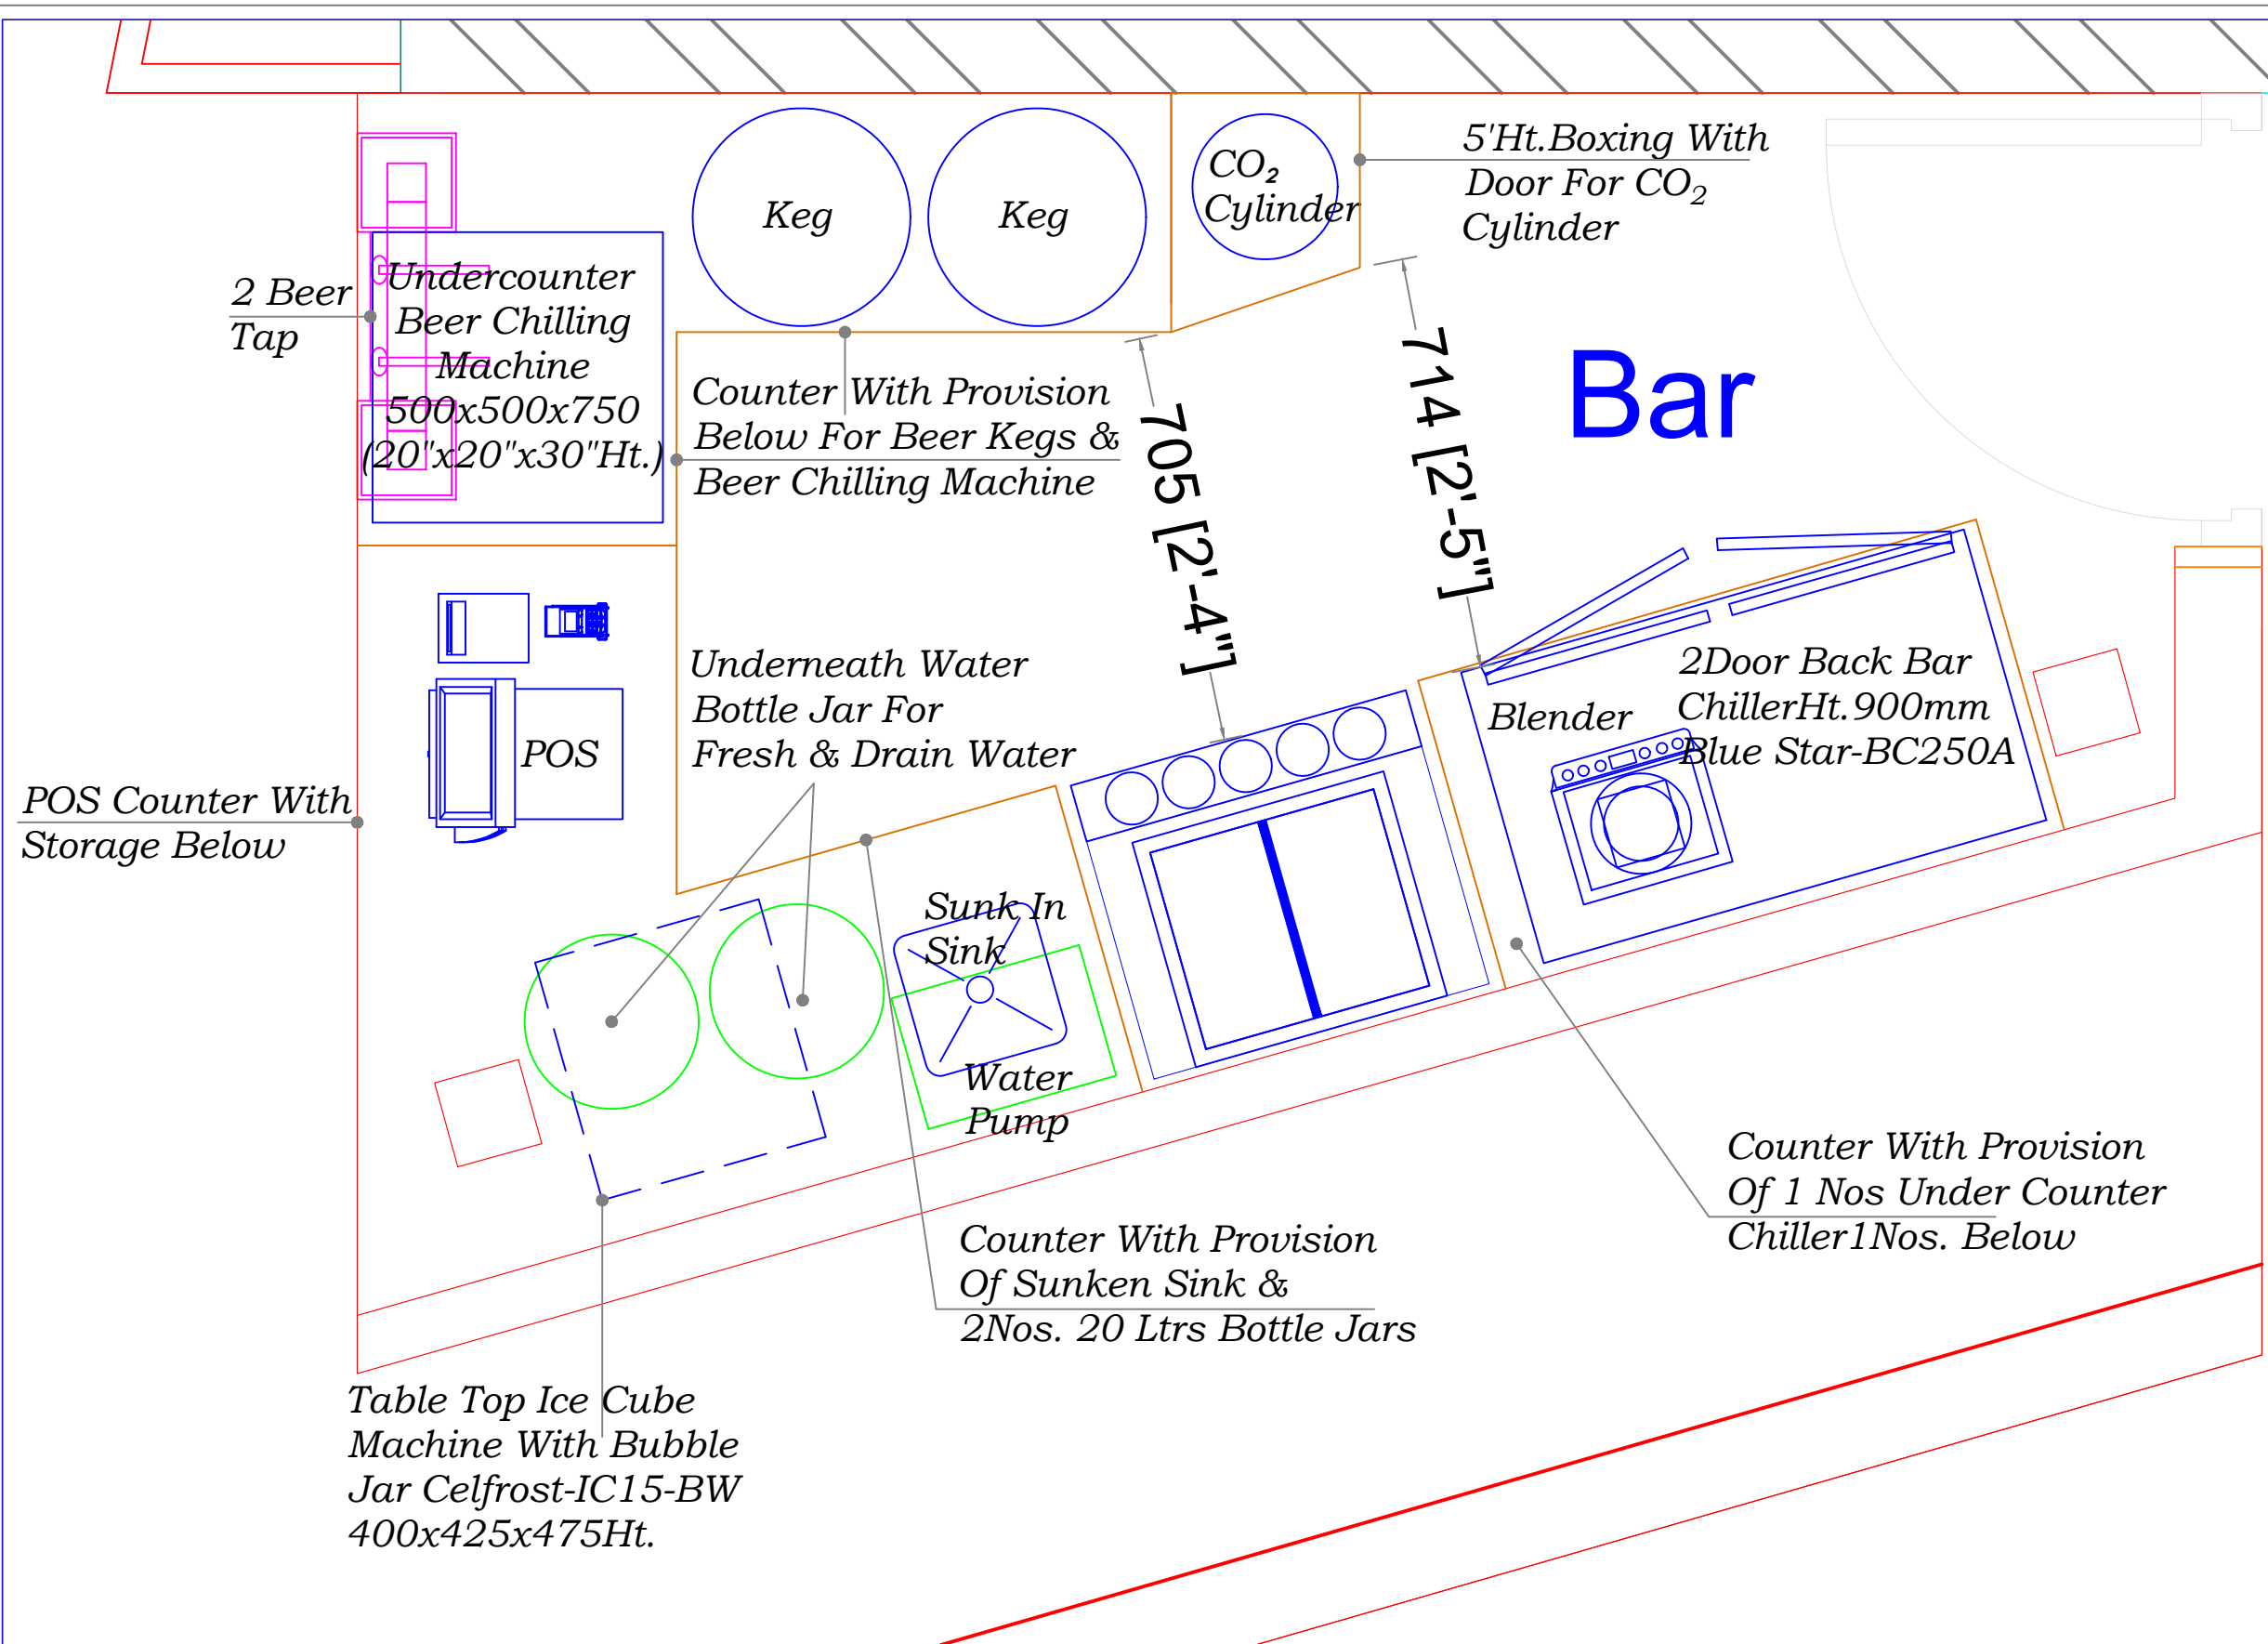

INHOUSE DESIGN

**BAR LAYOUT  
@  
CARL'S JR  
INT.BUS GATE  
HYDERABAD**




**LAYOUT APPROVED BY  
GD SIR ON WHATSAPP  
AT 05-10-2024**

SHEET DETAIL		All Dimensions Are In MM			DRAWING NAME	SHEET NUMBER	REVISION REASON		GFC ISSUED DATE
PROJECT	LOCATION	UNITNo.	DRAWN BY	START DATE			REVISION No.	DATE	
BAR LAYOUT	CARL'S JR @ INT.BUS GATE HYDERABAD		SAEED	2024-08-13	EQUIPMENT NAMING LAYOUT	01 OF 03			05-10-2024
			SCALE						
			NTS						



INHOUSE DESIGN

**BAR LAYOUT  
@  
CARL's JR  
INT.BUS GATE  
HYDERABAD**

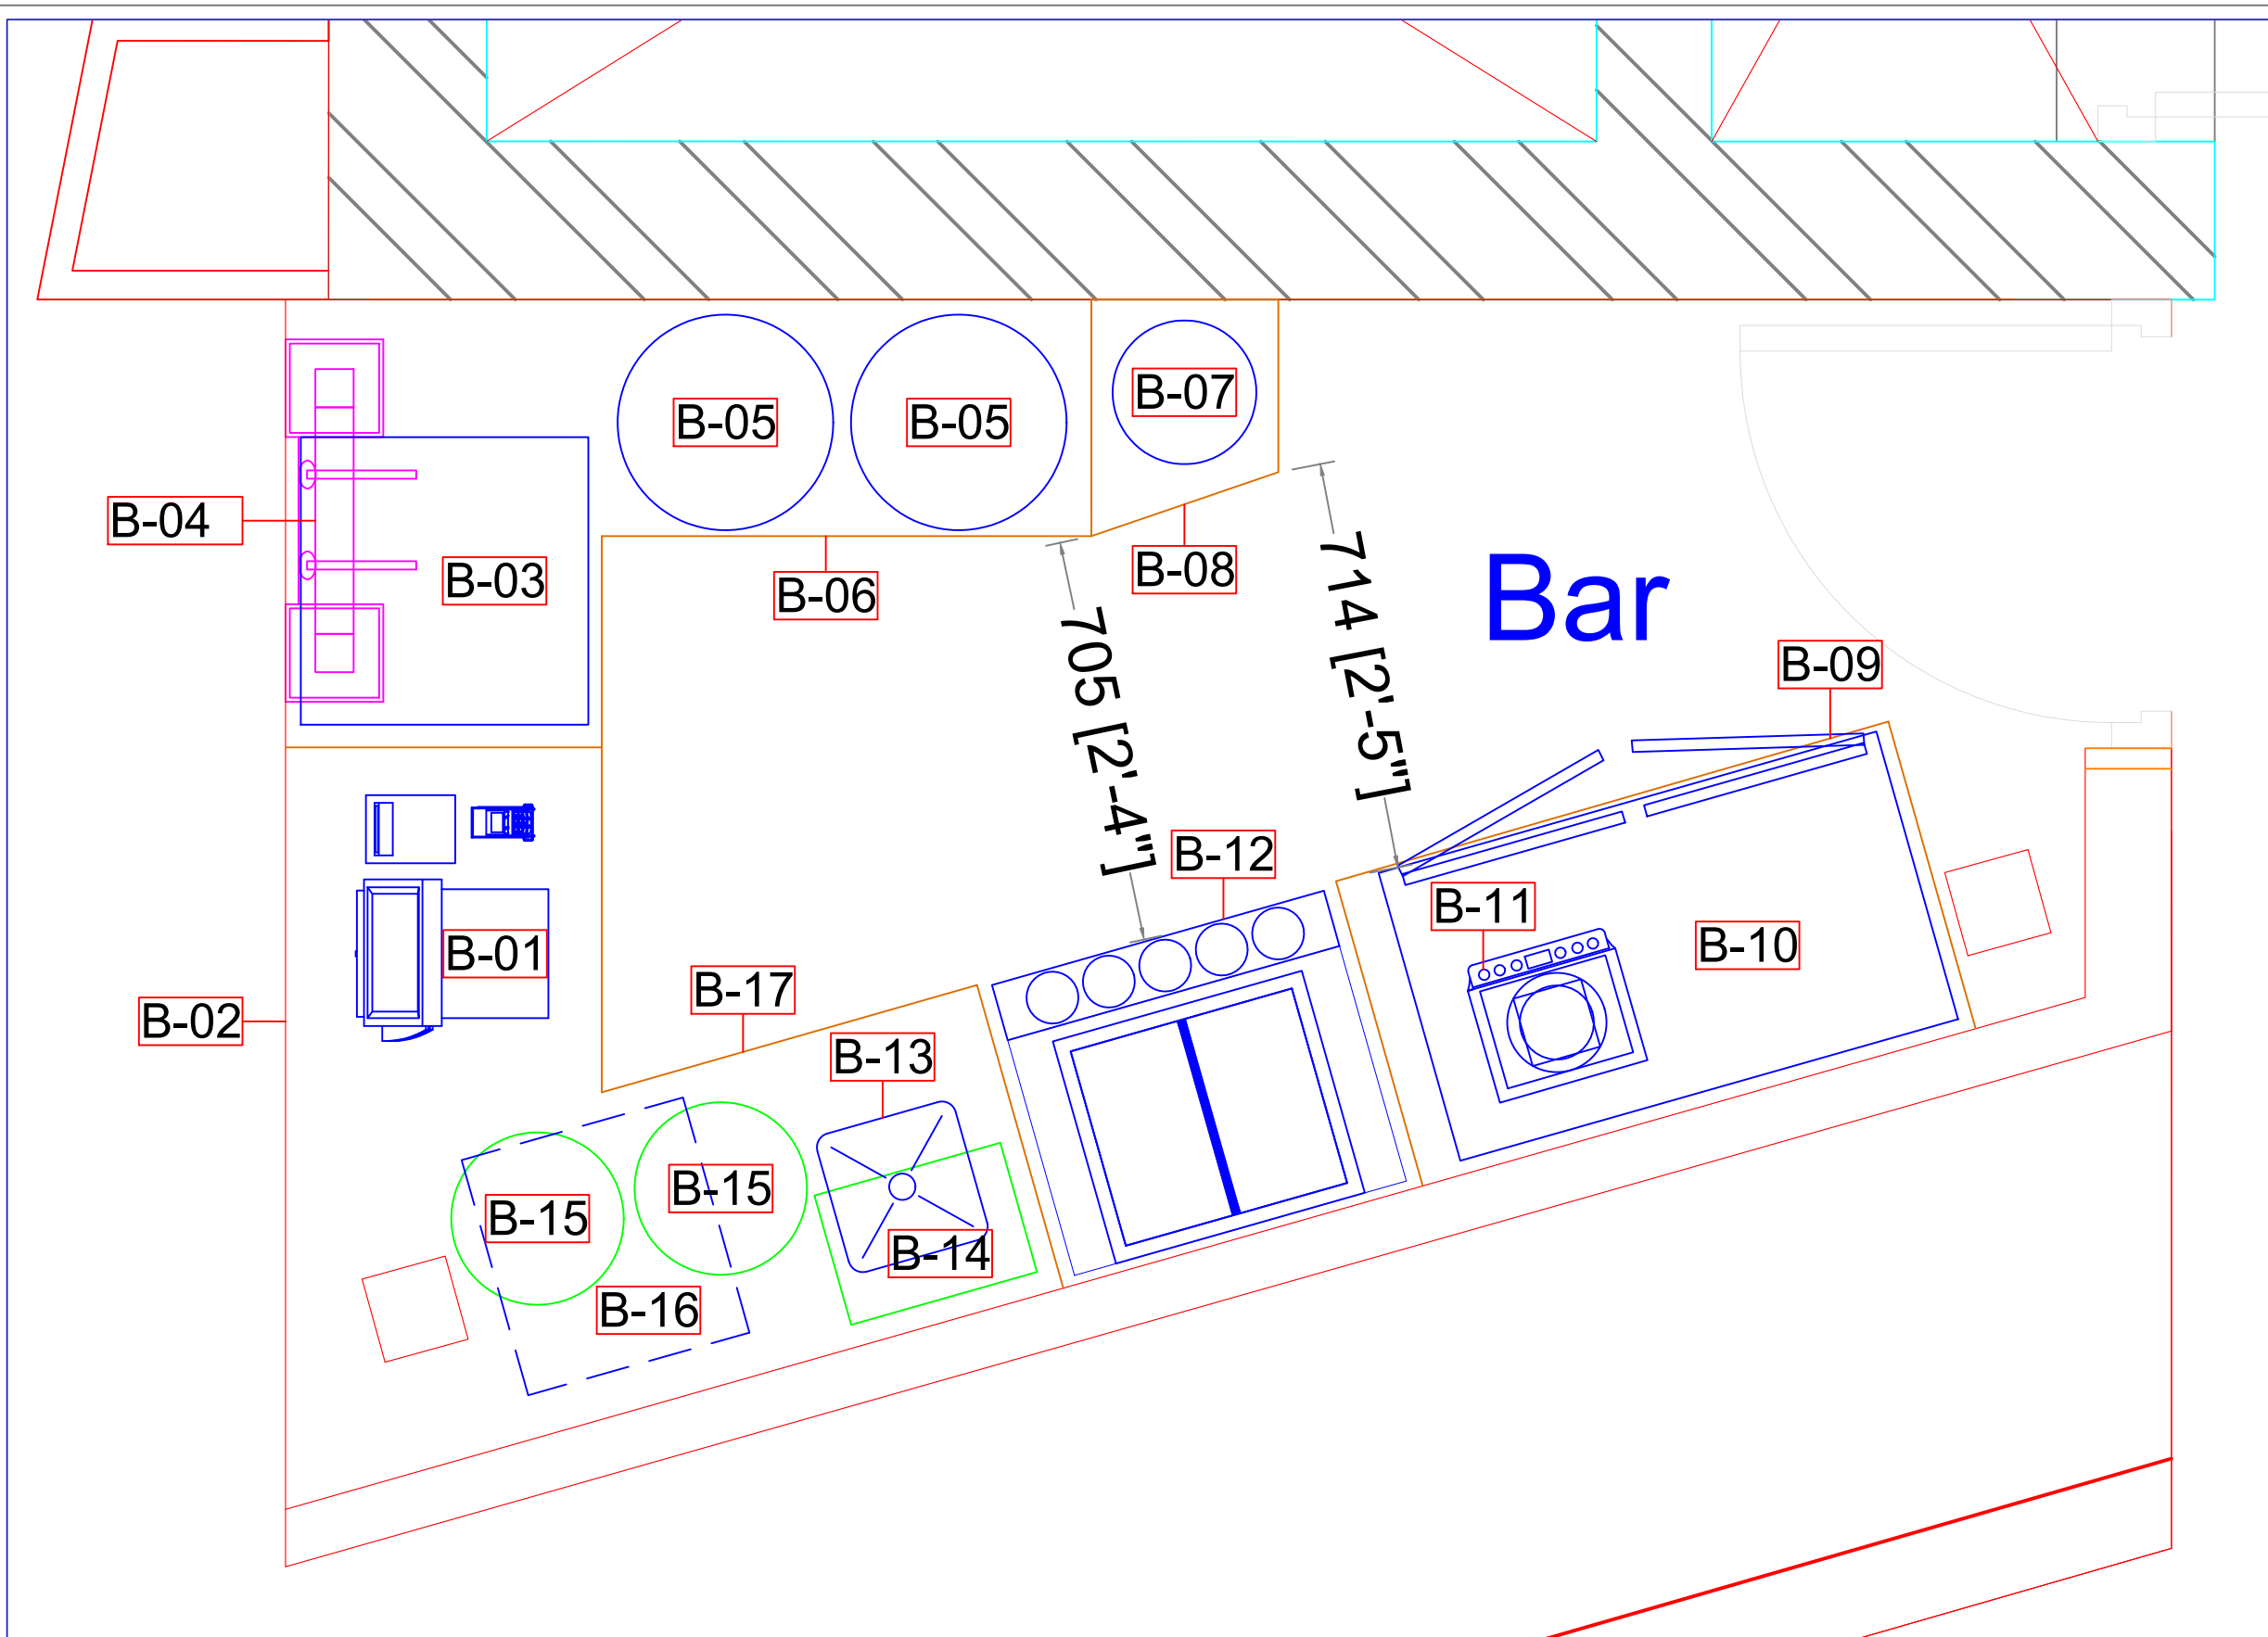


SHEET DETAIL		All Dimensions Are In MM			DRAWING NAME	SHEET NUMBER	REVISION REASON		GFC ISSUED DATE
PROJECT	LOCATION	UNITNo.	DRAWN BY	START DATE			REVISION No.	DATE	
BAR LAYOUT	CARL's JR @ INT.BUS GATE HYDERABAD		SAEED	2024-08-13	EQUIP.NUMBERING LAYOUT	02 OF 03			05-10-2024
			SCALE						
			NTS						



Travel Food Services

INHOUSE DESIGN

**BAR LAYOUT  
@  
CARL's JR  
INT.BUS GATE  
HYDERABAD**

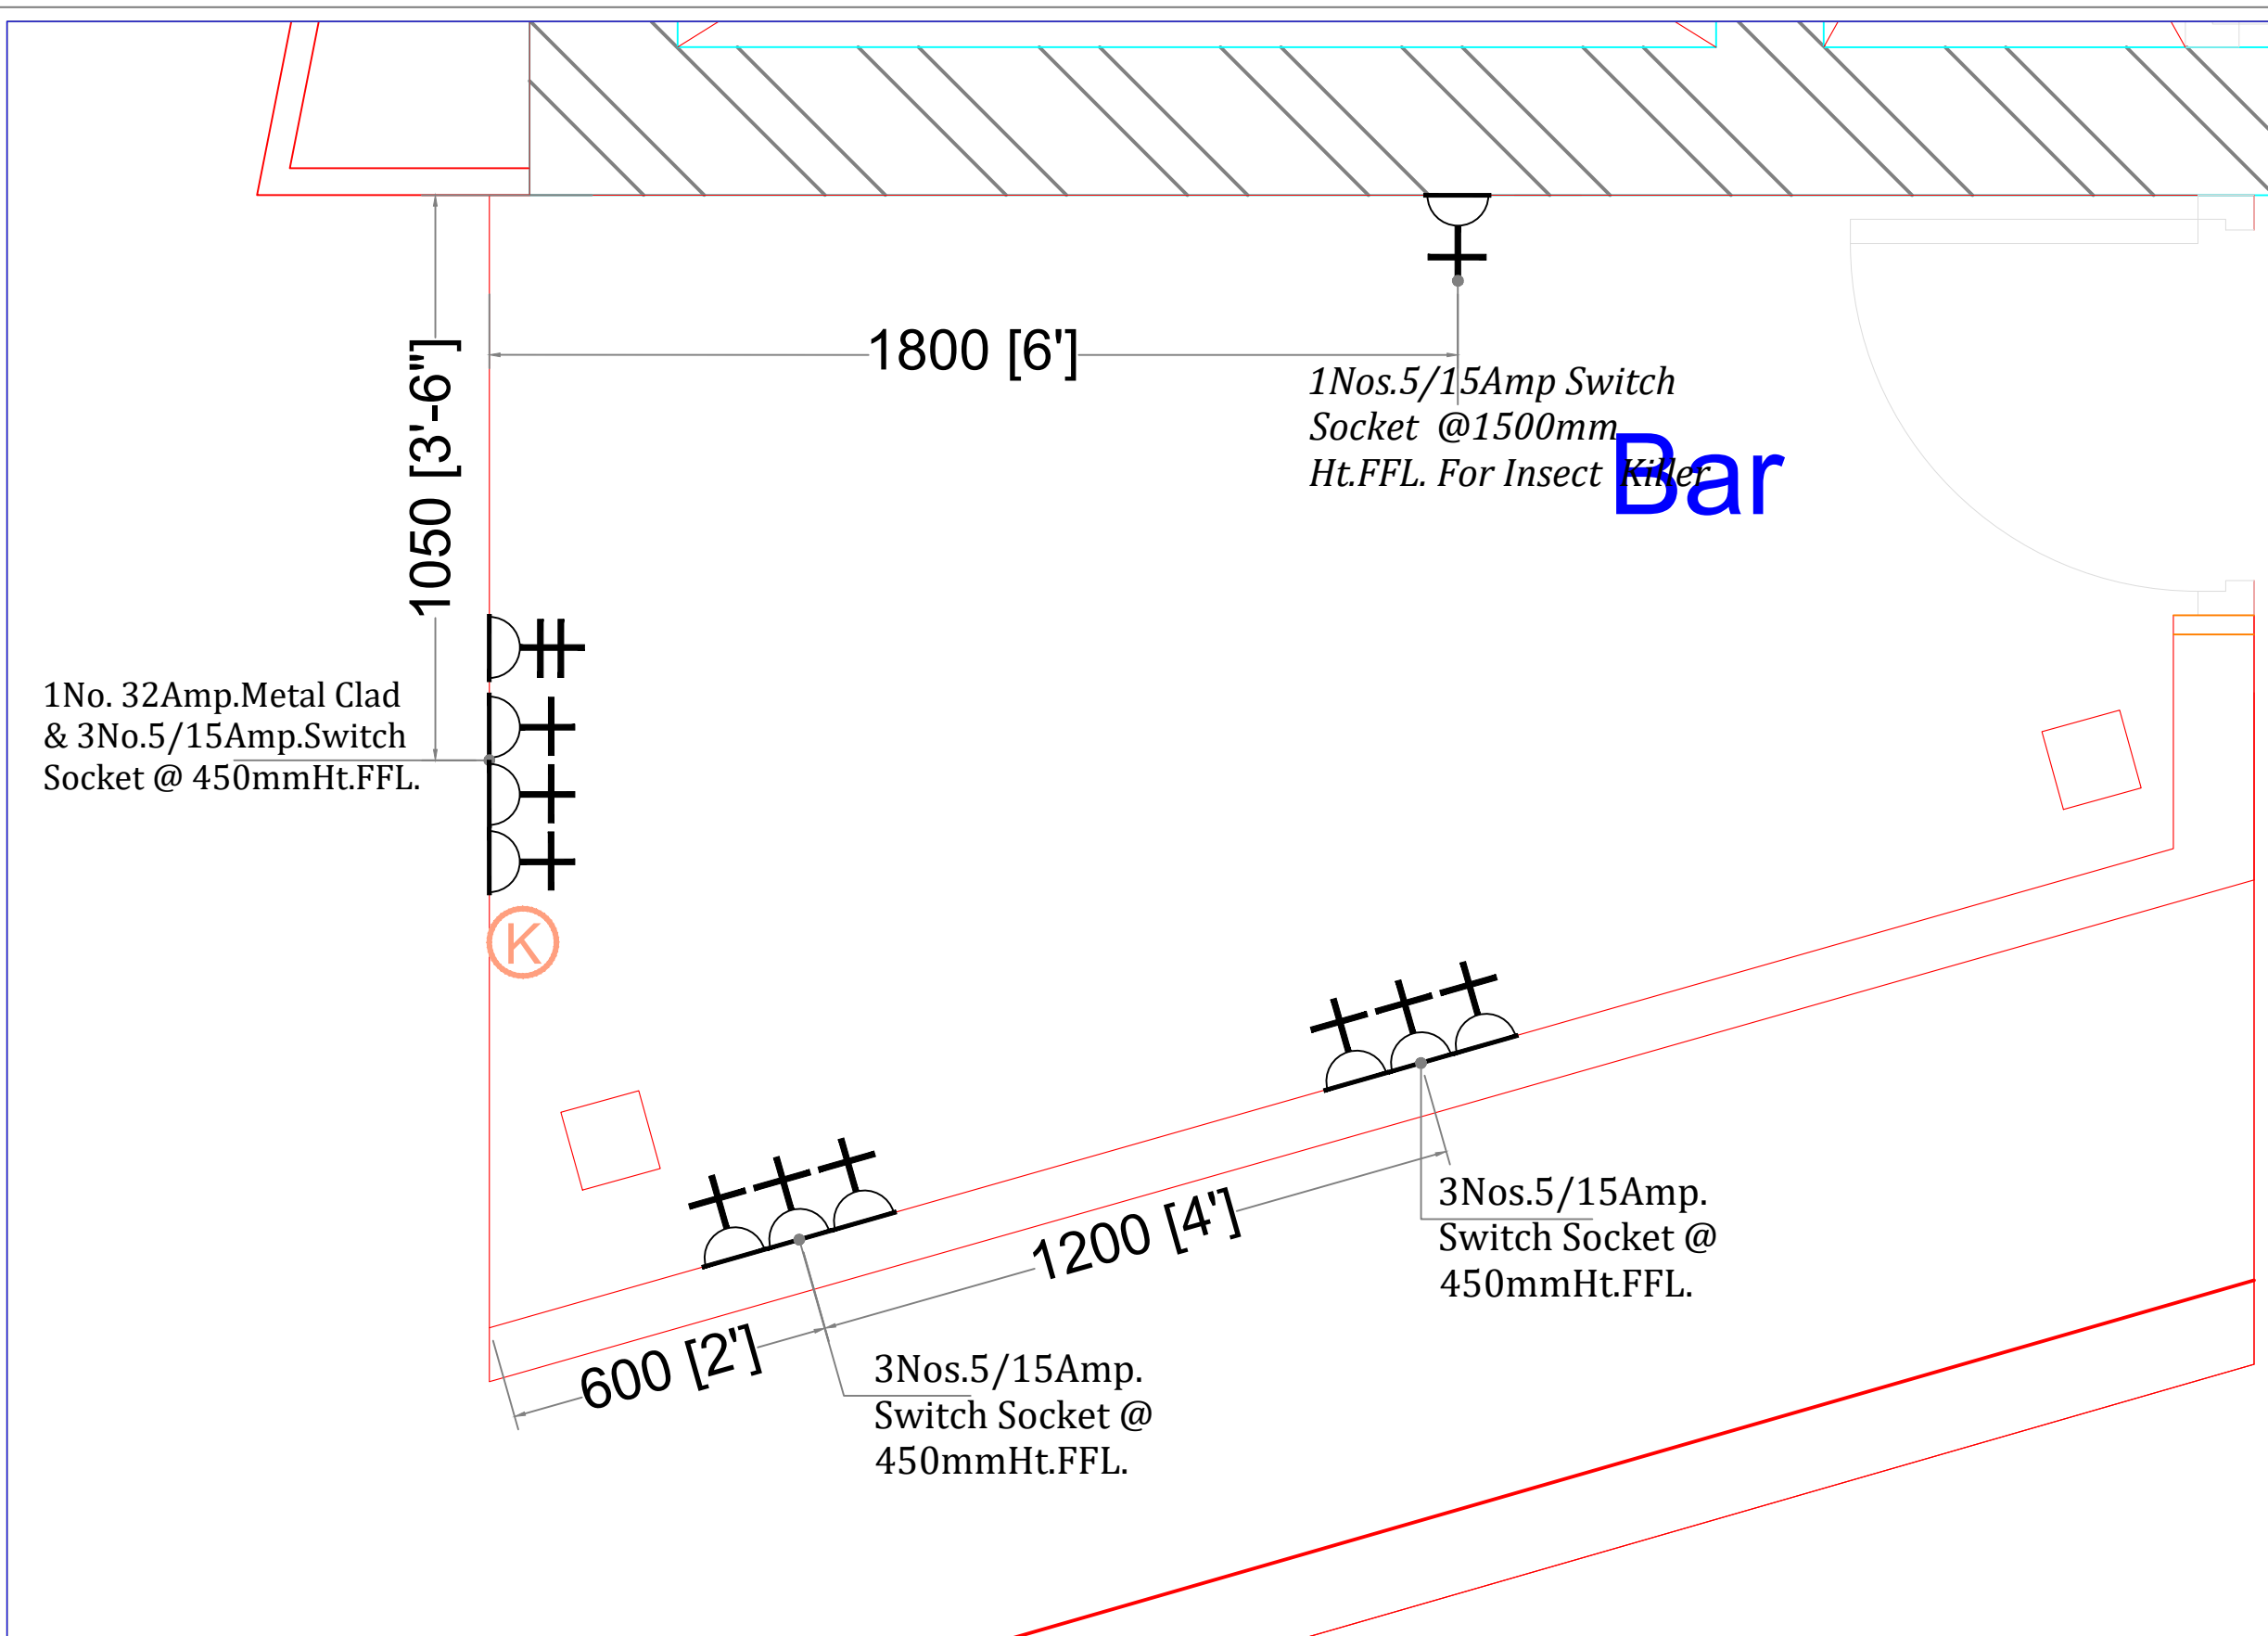

ELECTRICAL LEGEND	
	5 AMP PLUG POINT
	5/15 AMP POWER PLUG POINT (MODULAR SWITCH & SOCKET)
	20/32 AMP METAL CLAD WITH 20 AMP SP MCB & PLUG TOP
	3 PHASE SUPPLY
	COMPUTER POINT
	TELEPHONE POINT
	DATA CABLE POINT FOR KOT PRINTER
	INTERNET

SHEET DETAIL					All Dimensions Are In MM		DRAWING NAME	SHEET NUMBER	REVISION No.	DATE	REVISION REASON		GFC ISSUED DATE
PROJECT	LOCATION	UNITNo.	DRAWN BY	START DATE	REASON	REASON							
BAR LAYOUT	CARL's JR @ INT.BUS GATE HYDERABAD		SAEED	2024-08-13	ELECTRICAL LAYOUT	03 OF 03					05-10-2024		
			SCALE										
			NTS										