



C01	01.03.24	GOOD FOR CONSTRUCTION	HOD	NM
REV	DATE	DESCRIPTION	DRN	CHK

LIST OF DRAWINGS		
#	DESCRIPTION	DWG.No
1	COVER SHEET	02GA-001
2	APPROVED VISUALS	02GA-002
3	GENERAL NOTES & FINISHES SCHEDULE PART:A	02GA-003
4	FINISHES SCHEDULE PART:B FURNITURE, LIGHT & FIXTURE LEGEND	02GA-004
5	DETAIL DRAWING LEGEND	02GA-005
PLANS		
6	GENERAL ARRANGEMENT PLAN	02GA-100
7	EQUIPMENT LAYOUT	02GA-101
8	SETTING OUT PLAN	02GA-102
9	RCP+LIGHTING LAYOUT-PART:A	02GA-103
10	RCP+LIGHTING LAYOUT-PART:B	02GA-104
11	FLOORING LAYOUT	02GA-105
12	WATER PROOFING LAYOUT	02GA-106
13	FINISHES PLAN	02GA-107
ELEVATIONS & SECTIONS		
14	ELEVATION-01	03IL-300
15	ELEVATION-02	03IL-301
16	ELEVATION-03	03IL-302

17	ELEVATION-04	03IL-303
18	SECTION-01	03IL-304
19	SECTION-02	03IL-305
DETAIL DRAWINGS		
20	J01-FRONT COUNTER DETAIL-PART:A	04DE-400
21	J01-FRONT COUNTER DETAIL-PART:B	04DE-401
22	J01-FRONT COUNTER DETAIL-PART:C	04DE-402
23	J02-REAR COUNTER DETAIL-PART:A	04DE-403
24	J02-REAR COUNTER DETAIL-PART:B	04DE-404
25	J03-BULKHEAD DETAIL-PART:A	04DE-405
26	J03-BULKHEAD DETAIL-PART:B	04DE-406
27	J04-CONDIMENT UNIT&TROLLY STATION DETAIL-PART:A	04DE-407
28	J04-CONDIMENT UNIT&TROLLY STATION DETAIL-PART:B	04DE-408
29	J05-LEDGE DETAIL-PART:A	04DE-409
30	J05-LEDGE DETAIL-PART:B	04DE-410
31	J06-SERVICE CLOSET DETAIL	04DE-411
32	J07-OVERHEAD SHELF DETAIL	04DE-412
33	J08-BAFFLE CEILING DETAIL	04DE-413
34	J09-FACADE FRAMING DETAIL	04DE-414
35	J10-SIGNAGE DETAIL	04DE-415



PROJECT
FF-025
MILLIE COOKIES
HYDERABAD AIRPORT

DRAWING TITLE
COVER SHEET

SCALE NTS DATE 01.03.2024 DRAWN HOD A3 SHEET

STATUS
GOOD FOR CONSTRUCTION


ORG	PROJECT NO	DRAWING TYPE	NUMBER	REV
TFS	XXXX	02GA	001	C01



VIEW-01



VIEW-02

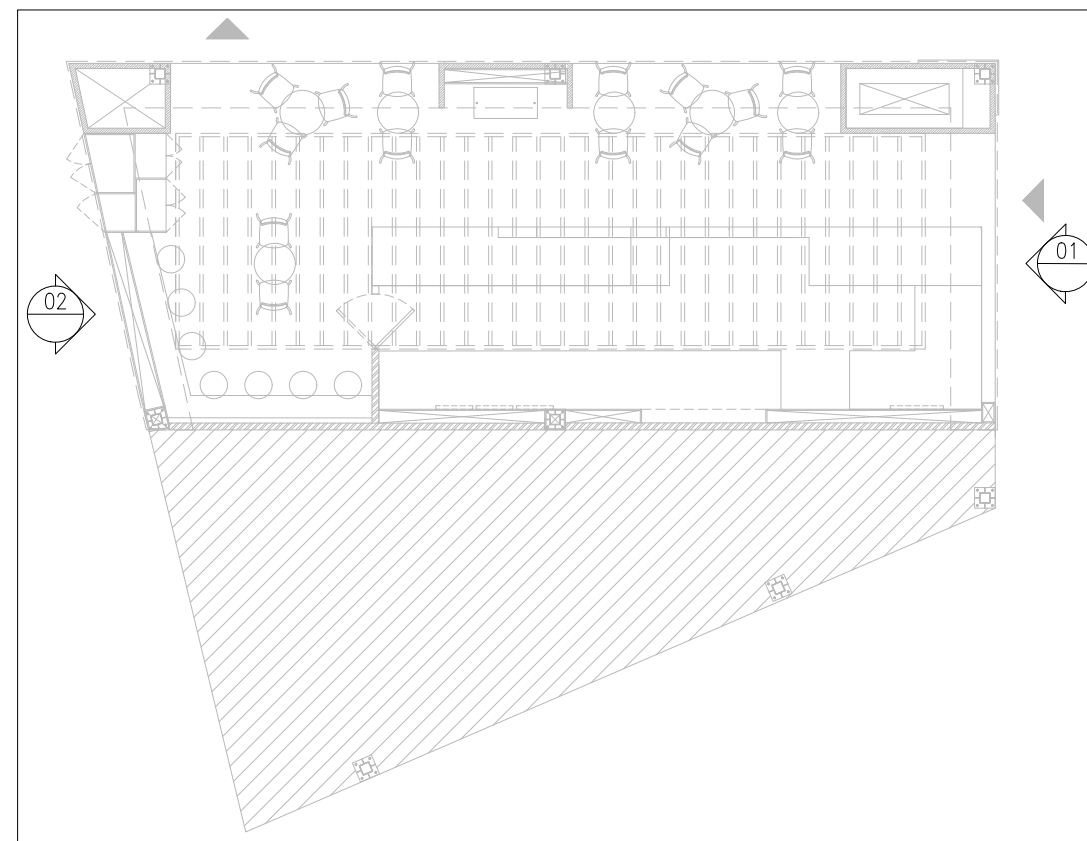

KEY PLAN

REV	DATE	DESCRIPTION	HOD	NM	DRN	CHK
C01	01.03.24	GOOD FOR CONSTRUCTION				



PROJECT
FF-025
MILLIE COOKIES
HYDERABAD AIRPORT

DRAWING TITLE
APPROVED VISUALS

SCALE NTS DATE 01.03.2024 DRAWN HOD A3 SHEET

STATUS
GOOD FOR CONSTRUCTION

ORG	PROJECT NO	DRAWING TYPE	NUMBER	REV
TFS	XXXX	02GA	002	C01

GENERAL NOTES

ALL DIMENSIONS ARE IN MM UNLESS OTHERWISE MENTIONED.
DO NOT SCALE THE DRAWING.
FOLLOW WRITTEN DIMENSIONS ONLY. IN CASE OF ANY DISCREPANCY IN DIMENSIONS/DETAILS AT SITE,
PLEASE REFER IT BACK TO THE ARCHITECT.

THE MAIN CONTRACTOR IS EXPECTED TO COORDINATE THE DESIGNS/SITE EXECUTION WITH THE
DESIGNS/DETAILS/WORKS OF THE SUB-CONTRACTOR/ VENDOR (E.G. PLUMBING CONTRACTOR). IN
CASE OF ANY DISCREPANCY IN DIMENSIONS/DETAILS AT SITE, PLEASE REFER IT BACK TO THE
ARCHITECT.


THE DRAWINGS/ DETAILS PROVIDED ARE MEANT TO CLARIFY DESIGN INTENT/DESIGN APPEARANCE
ONLY. THE CONTRACTOR IS EXPECTED TO DEVELOP HIS/HER OWN DETAILS TO ENSURE STRUCTURAL
STABILITY/ FUNCTIONING OF THE DETAIL IN LINE WITH THE DESIGN INTENT GIVEN.

THE DRAWINGS/DETAILS PROVIDED DO NOT CONTAIN ANY IRONMONGERY (E.G. HINGES, SCREWS,
ANGLES ETC.) SPECIFICATIONS OR DETAILS. IT IS EXPECTED THE CONTRACTOR WILL SUITABLY DETAIL
THE BUILD-UPS WITH THE RIGHT FITTINGS/IRONMONGERY TO ENSURE STRUCTURAL STABILITY/
FUNCTIONING OF THE DETAIL IN LINE WITH THE DESIGN INTENT GIVEN.

ALL SHOP DRAWINGS, MAKE/MATERIAL, FIXTURES TO BE PRESENTED TO ARCHITECT FOR REVIEW AND
VALIDATION.

ALL TAP-OFF POINTS (E.G. FOR POWER, WATER, DRAINAGE ETC.) TO BE VALIDATED AT SITE PRIOR
TO COMMENCEMENT OF WORK.

SYMBOLS & ABBREVIATIONS

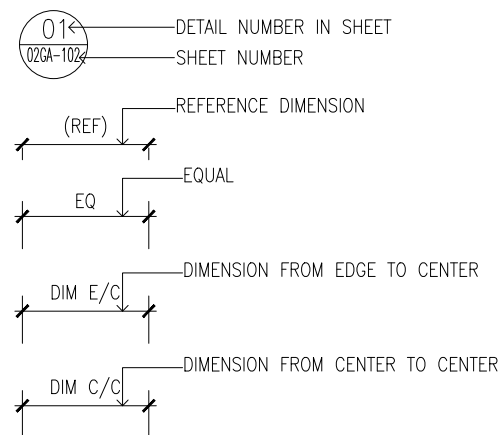

FINISHES SCHEDULE								
#	FINISH CODE	SURFACE	FINISH TYPE	DESCRIPTION/DETAIL	FINISH	REFERENCE/BRAND	WEBLINK	IMAGE
PAINT								
1	PT01	CHARCOAL PANEL, FRONT COUNTER FASCIA & BULKHEAD) BOX, SERVICE CLOSET GYPSUM CEILING	EMULSION	WHITE COLOUR PAINT	MATTE	DULUX TRADE PAINT/EQUIVALENT	https://www.dulux.co.uk/en/products/duluxsoft-sheen/colour/1935922?size=2.5&tabid=reviews	
2	PT02	BAFFLE CEILING, FACADE FRAMING, SIGNAGE (METAL FRAME), BULKHEAD	ENAMEL	WHITE COLOUR PAINT	MATTE	DULUX TRADE PAINT/EQUIVALENT	https://www.duluxtradepaints.co.uk/en/products/dulux-trade-enamel/colour/1780570?size=2.5	
3	PT03	WALL, SERVICE CLOSET & BOX	LACQUER	WHITE COLOUR LACQUER PAINT	GLOSSY	DULUX TRADE PAINT/EQUIVALENT	https://www.dulux.co.uk/en/products/duluxsoft-sheen/colour/1935922?size=2.5&tabid=reviews	
4	PT04	METAL FRAME (OVERHEAD SHELF), MDF PANEL	ENAMEL	HEATHER VIOLET COLOUR PAINT RAL:4003	MATTE	DULUX TRADE PAINT/EQUIVALENT	https://www.duluxtradepaints.co.uk/en/products/dulux-trade-enamel/colour/1780450?size=2.5	
5	PT05	WALL & MDF PANEL	EMULSION	PASTEL TURQUOISE COLOUR PAINT RAL:4003	MATTE	DULUX TRADE PAINT/EQUIVALENT	https://www.duluxtradepaints.co.uk/en/products/dulux-trade-enamel/colour/1780511?size=2.5	
6	PT06	WALL (5MM GROOVES)	EMULSION	GRAPHITE GREY COLOUR PAINT RAL:7024	MATTE	DULUX TRADE PAINT/EQUIVALENT	https://www.duluxtradepaints.co.uk/en/products/dulux-trade-enamel/colour/1780530?size=2.5	
LAMINATE								
7	LM01	LEDGE, SWING DOOR	LAMINATE	WHITE COLOUR LAMINATE	MATTE	CBTURY-WHITE CODE:101	https://www.centuryply.com/centurylaminates/single.php?product=179&product_name=white&cat=airy-white&sku=101	
8	LM02	INSIDE FASCIA (FRONT & REAR COUNTER, SERVICE CLOSET, CONDIMENT & TROLLY STATION) & REAR COUNTER FASCIA (FRONT COUNTER, REAR FASCIA)	LAMINATE	GREY COLOUR LAMINATE	MATTE	CBTURY-GREY CODE:80232	https://www.centuryply.com/centurylaminates/single.php?product=182	
9	LM03	CONDIMENT UNIT, TROLLY STATION	LAMINATE	CORAL LAMINATE	MATTE	CBTURY-CORAL CODE:90196	https://www.centuryply.com/centurylaminates/single.php?product=1753&product_name=coral&cat=pirki-and-red&sku=90196	
METAL								
10	MT01	SKIRTING	STAINLESS STEEL	STAINLESS STEEL	MATTE	LOCALLY SOURCED	NA	
COUNTER TOP								
11	SU01	FRONT COUNTER, REAR COUNTER, CONDIMENT, TROLLY STATION	CORIAN	SPARKLING GRANITA CORIAN TOP	MATTE	CORIAN® SOLID SURFACE SPARKLING GRANITA	https://coriandesignsamples.co.uk/2019/02/product/corians-solid-surface-sparkling-granita/	
CHARCOAL PANEL								
12	CP01	BULKHEAD & FRONT COUNTER	CHARCOAL PANEL	EMBOSSSED CHARCOAL PANEL FINISH WITH WHITE COLOUR PAINT (PT01)	MATTE	LOCALLY SOURCED	NA	
FLOORING								
13	FL01	FLOOR (SEATING AREA)	CONCRETE	POLISHED CONCRETE	MATTE	LOCALLY SOURCED	NA	
14	FL02	FLOOR (SEATING AREA)	PORCELAIN TILE	300X300MM PATTERNED PORCELAIN TILE	MATTE	ROYAL TILES /EQUIVALENT	https://royaltiles.com/boutique/	
15	FL03	FLOOR (SERVRY)	CERAMIC TILE	600X800MM GREY COLOUR KOTA STONE	MATTE	SIMPLO-SOLID DOVE SOLID ASH/EQUIVALENT	https://www.simplo.net/product-detail/minimo/minimo-collection/solid-dove-solid-ash	
16	FL04	FLOOR TRIM	STAINLESS STEEL	S.S 304 GRADE T-SHAPE TRANSITION TRIM	MATTE	SIS-PROFILES /EQUIVALENT	https://siprofile.com/product/304-ss-304-ss-transition-trim-available-in-sunesis-brand/	

C01 01.03.24 GOOD FOR CONSTRUCTION HOD NM
REV DATE DESCRIPTION DRN CHK








PROJECT
FF-025
MILIE COOKIES
HYDERABAD AIRPORT

DRAWING TITLE
GENERAL NOTES &
FINISHES SHEDULE PART:A






SCALE NTS DATE 01.03.2024 DRAWN HOD A3 SHEET

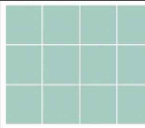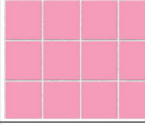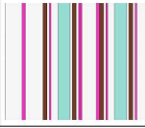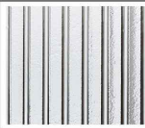STATUS
GOOD FOR CONSTRUCTION







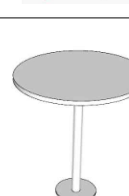

ORG PROJECT NO DRAWING TYPE NUMBER REV
TFS XXXX 02GA 003 C01

WALL TILES								
17	WT01	WALL.BOX	CERAMIC TILE	100X100MM PASTEL TURQUOISE COLOUR CERAMIC TILE WITH WHITE GROUT	GLOSSY	MYTYLES/EQUIVALENT	https://mytyles.com/product/ceramic-wall-tile-code24066ft-300x300mm-matt	
18	WT02	WALL.BOX	CERAMIC TILE	100X100MM HEATHER VIOLET COLOUR CERAMIC TILE WITH WHITE GROUT	GLOSSY	MYTYLES/EQUIVALENT	https://mytyles.com/product/ceramic-subway-wall-tile-code12102-75x300mm-glossy	
GRAPHICS								
19	GR01	WALL & BULKHEAD	VINYL	VINYL STICKER	NEUTRAL	LOCALLY SOURCED	NA	
GLASS								
20	GL01	FACADE FRAMING,REAR COUNTER WALL.BOX	NEUTRAL	8MM THK FLUTED GLASS	NEUTRAL	LOCALLY SOURCED	NA	
21	GL02	IMPULSE UNIT,FRONT COUNTER	NEUTRAL	8MM THK TOUGHENED GLASS	NEUTRAL	LOCALLY SOURCED	NA	
CONTRACTOR TO SUBMIT SAMPLES FOR APPROVAL								

FURNITURE LEGEND

SL.NO	CODE	DESCRIPTION	QTY	REFERENCE/BRAND	IMAGE
1	CH1	DINING CHAIR-01 ELBOW CHAIR WHITE PAINTED METAL FRAME & SEAT UPHOLSTERED WITH PASTEL TURQUOISE COLOUR LEATHERETTE CHAIR HEIGHT:775MM CHAIR WIDTH:440MM CHAIR LENGTH:420MM SEAT HEIGHT:485MM	8	SOURCE LOCALLY	
2	CH2	DINING CHAIR-02 ELBOW CHAIR WHITE PAINTED METAL FRAME & SEAT UPHOLSTERED WITH HEATHER VIOLET COLOUR LEATHERETTE CHAIR HEIGHT:775MM CHAIR WIDTH:440MM CHAIR LENGTH:420MM SEAT HEIGHT:485MM	6	SOURCE LOCALLY	
3	HC1	HIGH CHAIR-01 ROUND BAR STOOL FINISHED IN PASTEL TURQUOISE COLOUR METAL FRAME AND WHITE COLOUR LEATHERETTE CUSHION STOOL DIA:400MM SEAT HEIGHT:765MM	4	SOURCE LOCALLY	
4	HC2	HIGH CHAIR-02 ROUND BAR STOOL FINISHED IN HEATHER VIOLET COLOUR METAL FRAME AND WHITE COLOUR LEATHERETTE CUSHION STOOL DIA:400MM SEAT HEIGHT:765MM	3	SOURCE LOCALLY	
5	TB	ROUND TABLE HEIGHT: 750MM DIA:600MM 40MM THK WOODEN WHITE LAMNATED TABLE TOP AND CIRCULAR HOLLOW METAL LEGS WITH CIRCULAR METAL BASE PLATE	6	SOURCE LOCALLY	

LIGHT & FIXTURE LEGEND

SL.NO	CODE	DESCRIPTION	Qty	REFERENCE/BRAND	IMAGE
1	LT01	PENDANT LIGHT-01 WABI SABI PENDANT LIGHTS BODY COLOUR:PURE WHITE LIGHT TEMP:3000K	5	https://www.crosby.co.in/product/pendant-light-impressive-lamp-with-typical-japanese-wabi-sabi-style/?v=54b5fb00fe8	
2	LT02	PENDANT LIGHT-02 COB PENDANT LAMP- FS3036-15 BODY COLOUR:WHITE LENGTH:400MM LIGHT TEMP:3000K	6	https://www.est.net.in/indoor-led-lighting/led-pendant-lights/pendant-light-fs3036-15/	
3	LT03	PENDANT LIGHT-03 COB PENDANT LAMP- FS3036-15 BODY COLOUR:WHITE LENGTH:1000MM LIGHT TEMP:3000K	3	https://www.est.net.in/indoor-led-lighting/led-pendant-lights/pendant-light-fs3036-15/	
4	LT04	RECESSED DOWN LIGHT CORE LINE SLIMDOWNLIGHT DIA:205MM WALLTAGE:22.5W LIGHT TEMP:3000K	7	https://www.lighting.philips.com/prq/indoor-luminaires/dawnlights/coreline-slim-downlight/910505101197_EU/product	
5	LT05	LED STRIP LIGHT WITH DIFFUSER LIGHT TEMP:3000K	AS PER DWG	https://havells.com/en/consumer/lighting/led%20strips/flexion-strip-light/flexion-led-strip-24-w-rgb.html	
6	LT06	FLEXIBLE LED STRIP LIGHT LIGHT TEMP:3000K	AS PER DWG	https://pasolite.in/product/led-neon-flex-strip-light-ac-220v-2/	
7	LT07	10MM WIDTH LED STRIP LIGHT CHANNEL, ALUMINUM EXTRUSION PROFILE V SHAPE 46 INCHES (1.17M), 4C16	AS PER DWG	https://www.bestledstrip.com/led-strip-channel-with-diffuser-v-shape-aluminum-profile-41616R/	
8	DD	43" DIGITAL DISPLAY (VERTICAL ORIENTATION) 1080P SMART LED TV - 43" CLASS (42.5" DIAG)/EQUIVALENT	3	https://www.lg.com/us/tvs/lg-43LE6300-smart-led-tv	

C01 01.03.24 GOOD FOR CONSTRUCTION HOD NM
REV DATE DESCRIPTION DRN CHK




PROJECT
FF-025
MILIE COOKIES
HYDERABAD AIRPORT

DRAWING TITLE
FINISHES SHEDULE PART:B
FURNITURE,LIGHT & FIXTURE LEGEND

SCALE NTS DATE 01.03.2024 DRAWN HOD A3 SHEET

STATUS
GOOD FOR CONSTRUCTION

ORG PROJECT NO DRAWING TYPE NUMBER REV
TFS XXXX 02GA 004 C01

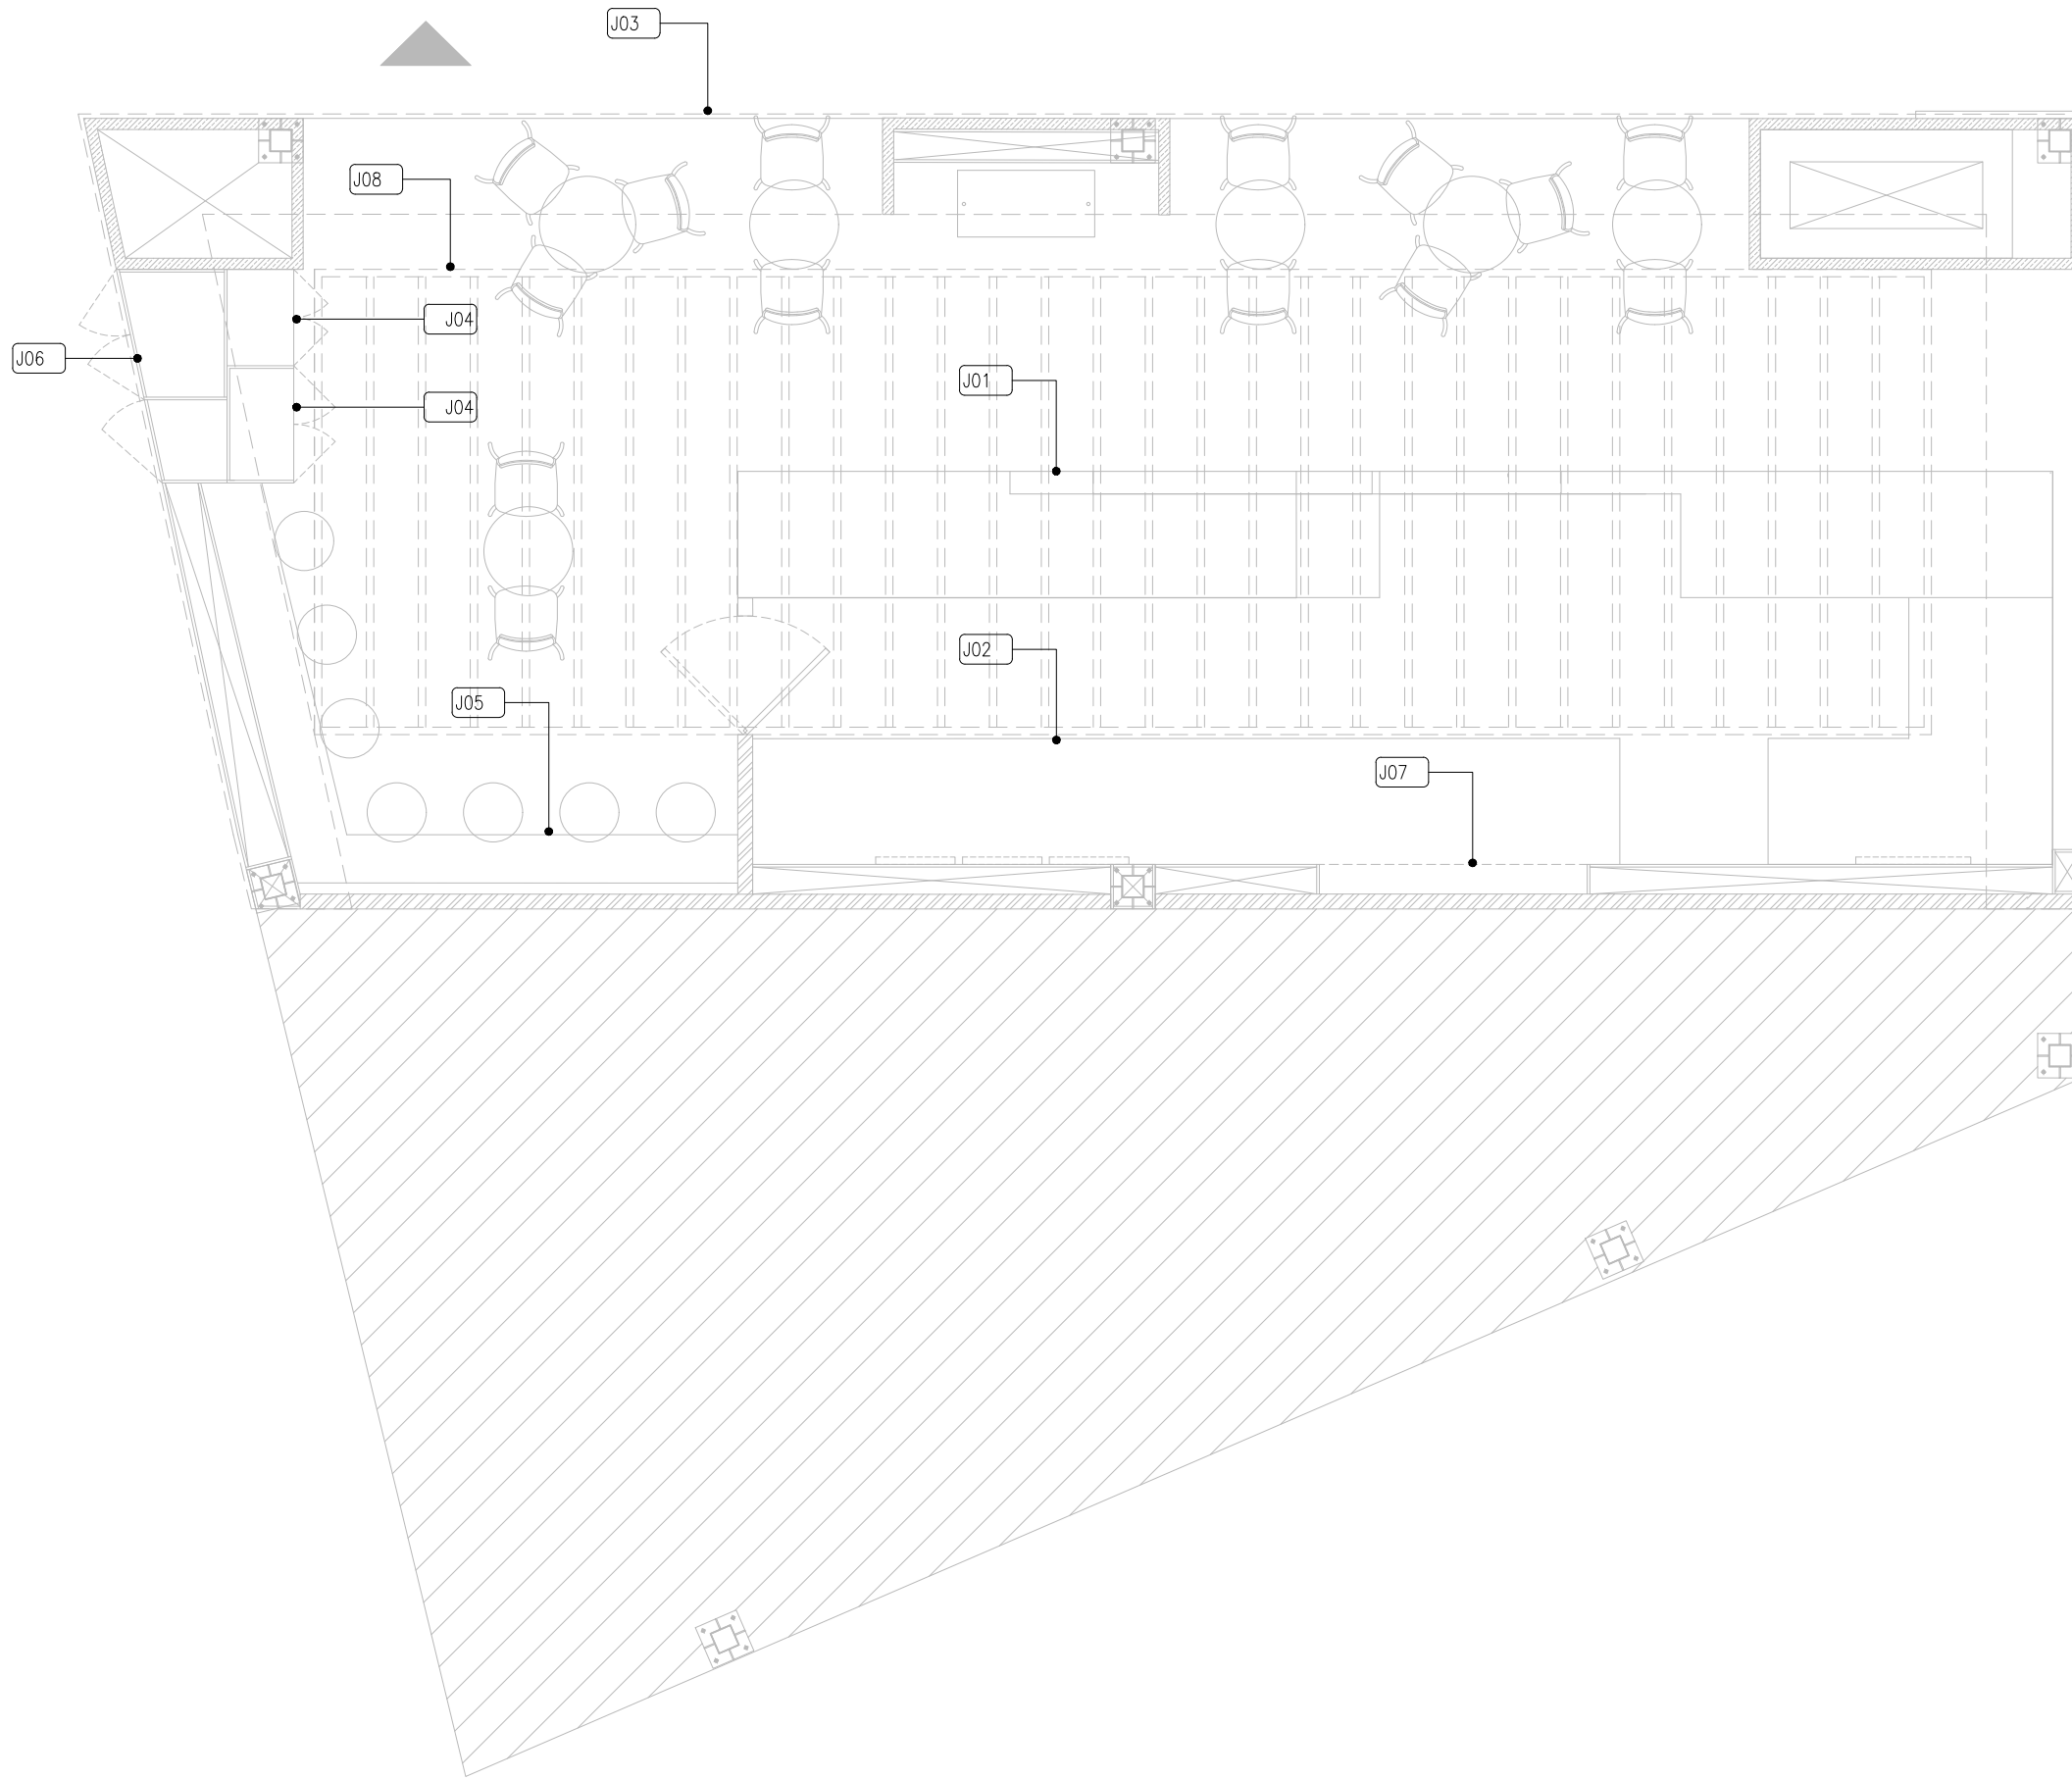

DETAIL DRAWING LEGEND		
CODE	DESCRIPTION	ADDITIONAL INFORMATION
J01	FRONT COUNTER	REFER: 04DE-400 TO 04DE-402
J02	REAR COUNTER	REFER: 04DE-403 TO 04DE-404
J03	BULKHEAD	REFER: 04DE-405 TO 04DE-406
J04	CONDIMENT UNIT&TROLLY STATION	REFER: 04DE-407 TO 04DE-408
J05	LEDGE	REFER: 04DE-409 TO 04DE-410
J06	SERVICE CLOSET	REFER: 04DE-411
J07	OVERHEAD SHELF	REFER: 04DE-412
J08	BAFFLE CEILING	REFER: 04DE-413
J09	FACADE FRAMING	REFER: 04DE-414
J10	SIGNAGE	REFER: 04DE-415

01 DETAIL DRAWING LEGEND
02GA-005 1:50

REV	DATE	DESCRIPTION	HOD	NM	DRN	CHK
C01	01.03.24	GOOD FOR CONSTRUCTION				



PROJECT
FF-025
MILIE COOKIES
HYDERABAD AIRPORT

DRAWING TITLE
DETAIL DRAWING LEGEND


SCALE 1:50 DATE 01.03.2024 DRAWN HOD A3 SHEET

STATUS
GOOD FOR CONSTRUCTION

ORG	PROJECT NO	DRAWING TYPE	NUMBER	REV
TFS	XXXX	02GA	005	C01

ALL DIMENSIONS MUST BE CHECKED ON SITE
INFORM THE ARCHITECT OF ANY DISCREPANCIES PRIOR TO CONSTRUCTION

- - - - - INDICATES UNIT DEMISE
- - - - - INDICATES LOCATION OF PROPOSED SIGNAGE
- - - - - INDICATES LOCATION OF SUSPENDED SIGNAGE

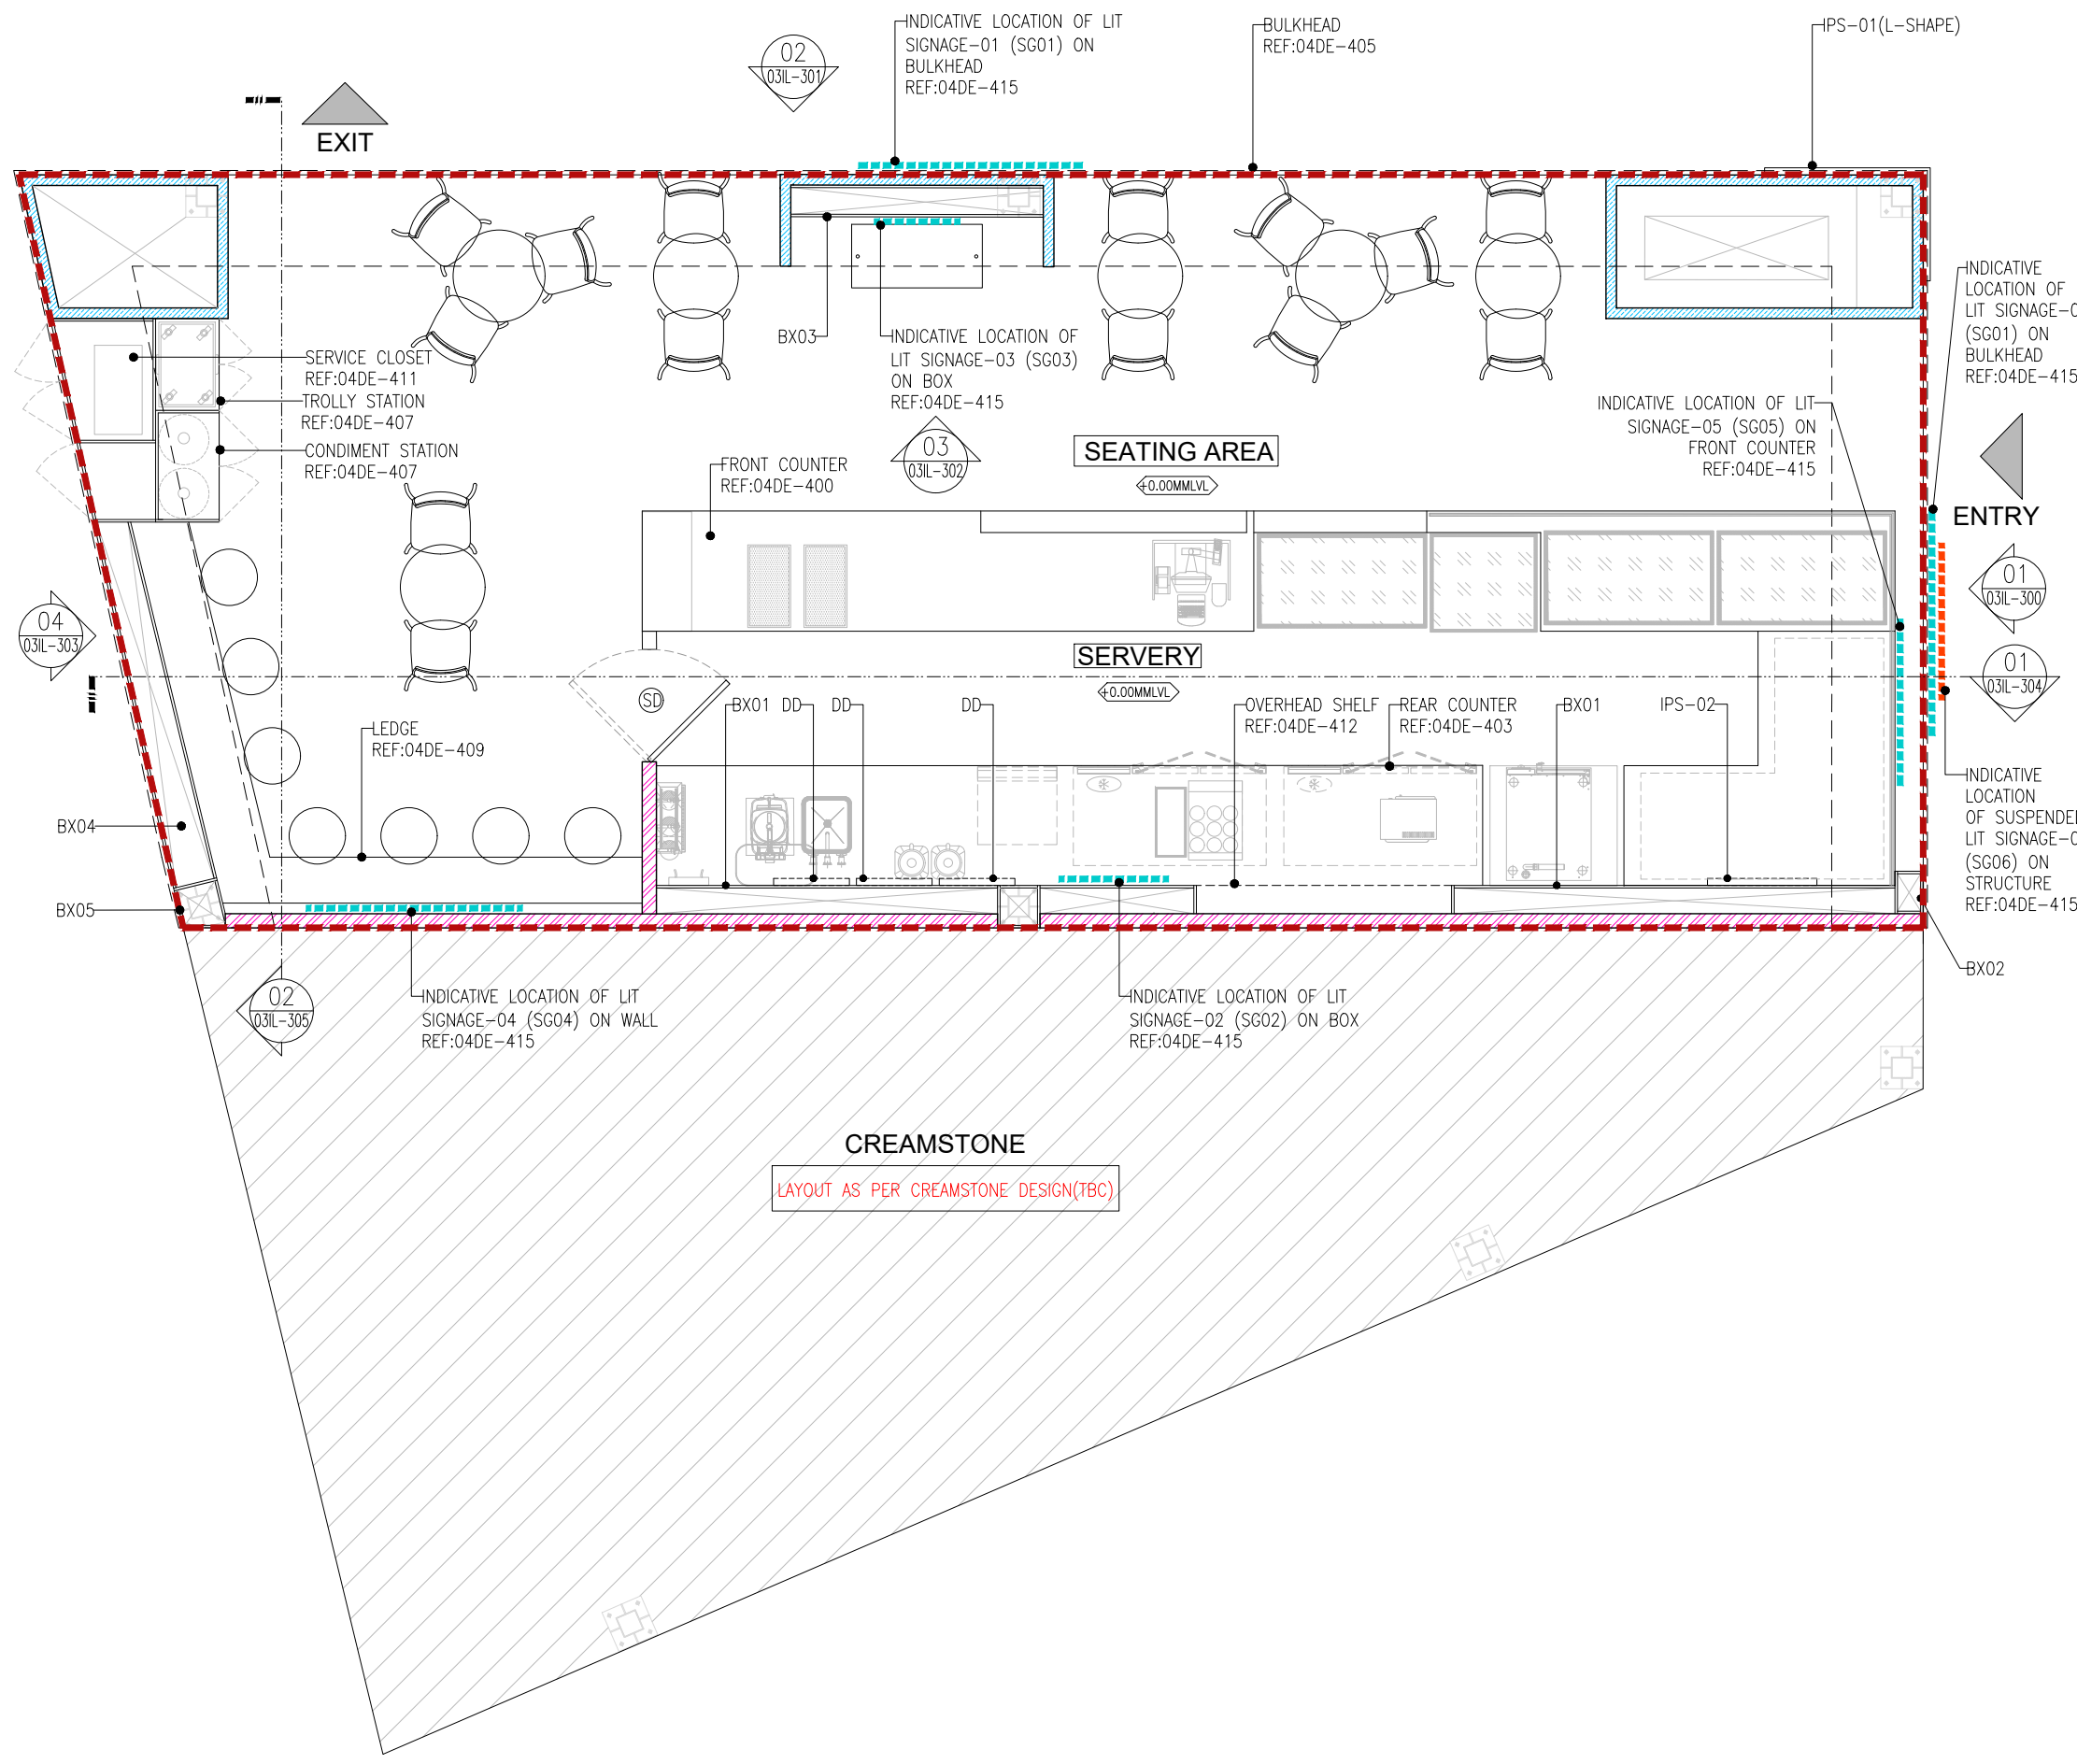

WALL LEGEND		
PATTERN	TYPE	HEIGHT
	PROPOSED 100MM THK DRY PARTITION WALL	+3000 MM
	PROPOSED 75MM THK LOW HEIGHT MASONRY WALL	+3000MM

DIGITAL DISPLAY			
CODE	SIZE	NAME	NOS.
DD	43"	DIGITAL DISPLAY (VERTICAL ORIENTATION)	3

AREA STATEMENT			IPS PANEL			
#	DESCRIPTION	AREA/M ²	CODE	SIZE	NAME	NOS.
1	SERVERY	25.33	IPS-01	1975X3300MM	IPS PANEL(L-SHAPE)	1
2	SEATING	43.41	IPS-02	776X1420MM	IPS PANEL	1
TOTAL		68.74				

DOOR SCHEDULE						
CODE	SIZE	COUNT	TYPE	SWING	LOCK	FIRE RATING
SD	800X800	1	SWING DOOR	DOUBLE	NO	1HR

COVERS		
#	DESCRIPTION	NOS
1	DINING SEATING	14
2	HIGH SEATING	07
TOTAL		21

BOX LEGEND			
CODE	NAME	SIZE(MM)	HEIGHT
BX01	BOX-01	AS PER DWG	+3000MM
BX02	BOX-02	AS PER DWG	+3000MM
BX03	BOX-03	AS PER DWG	+3000MM
BX04	BOX-04	AS PER DWG	+1100MM
BX05	BOX-05	AS PER DWG	+3000MM

C01 01.03.24 GOOD FOR CONSTRUCTION HOD NM
REV DATE DESCRIPTION DRN CHK



PROJECT
FF-025
MILIE COOKIES
HYDERABAD AIRPORT


DRAWING TITLE
GENERAL ARRANGEMENT PLAN

01 GENERAL ARRANGEMENT PLAN
02GA-100 1:50

SCALE 1:50 DATE 01.03.2024 DRAWN HOD A3 SHEET

STATUS
GOOD FOR CONSTRUCTION

ORG PROJECT NO DRAWING TYPE NUMBER REV
TFS XXXX 02GA 100 C01

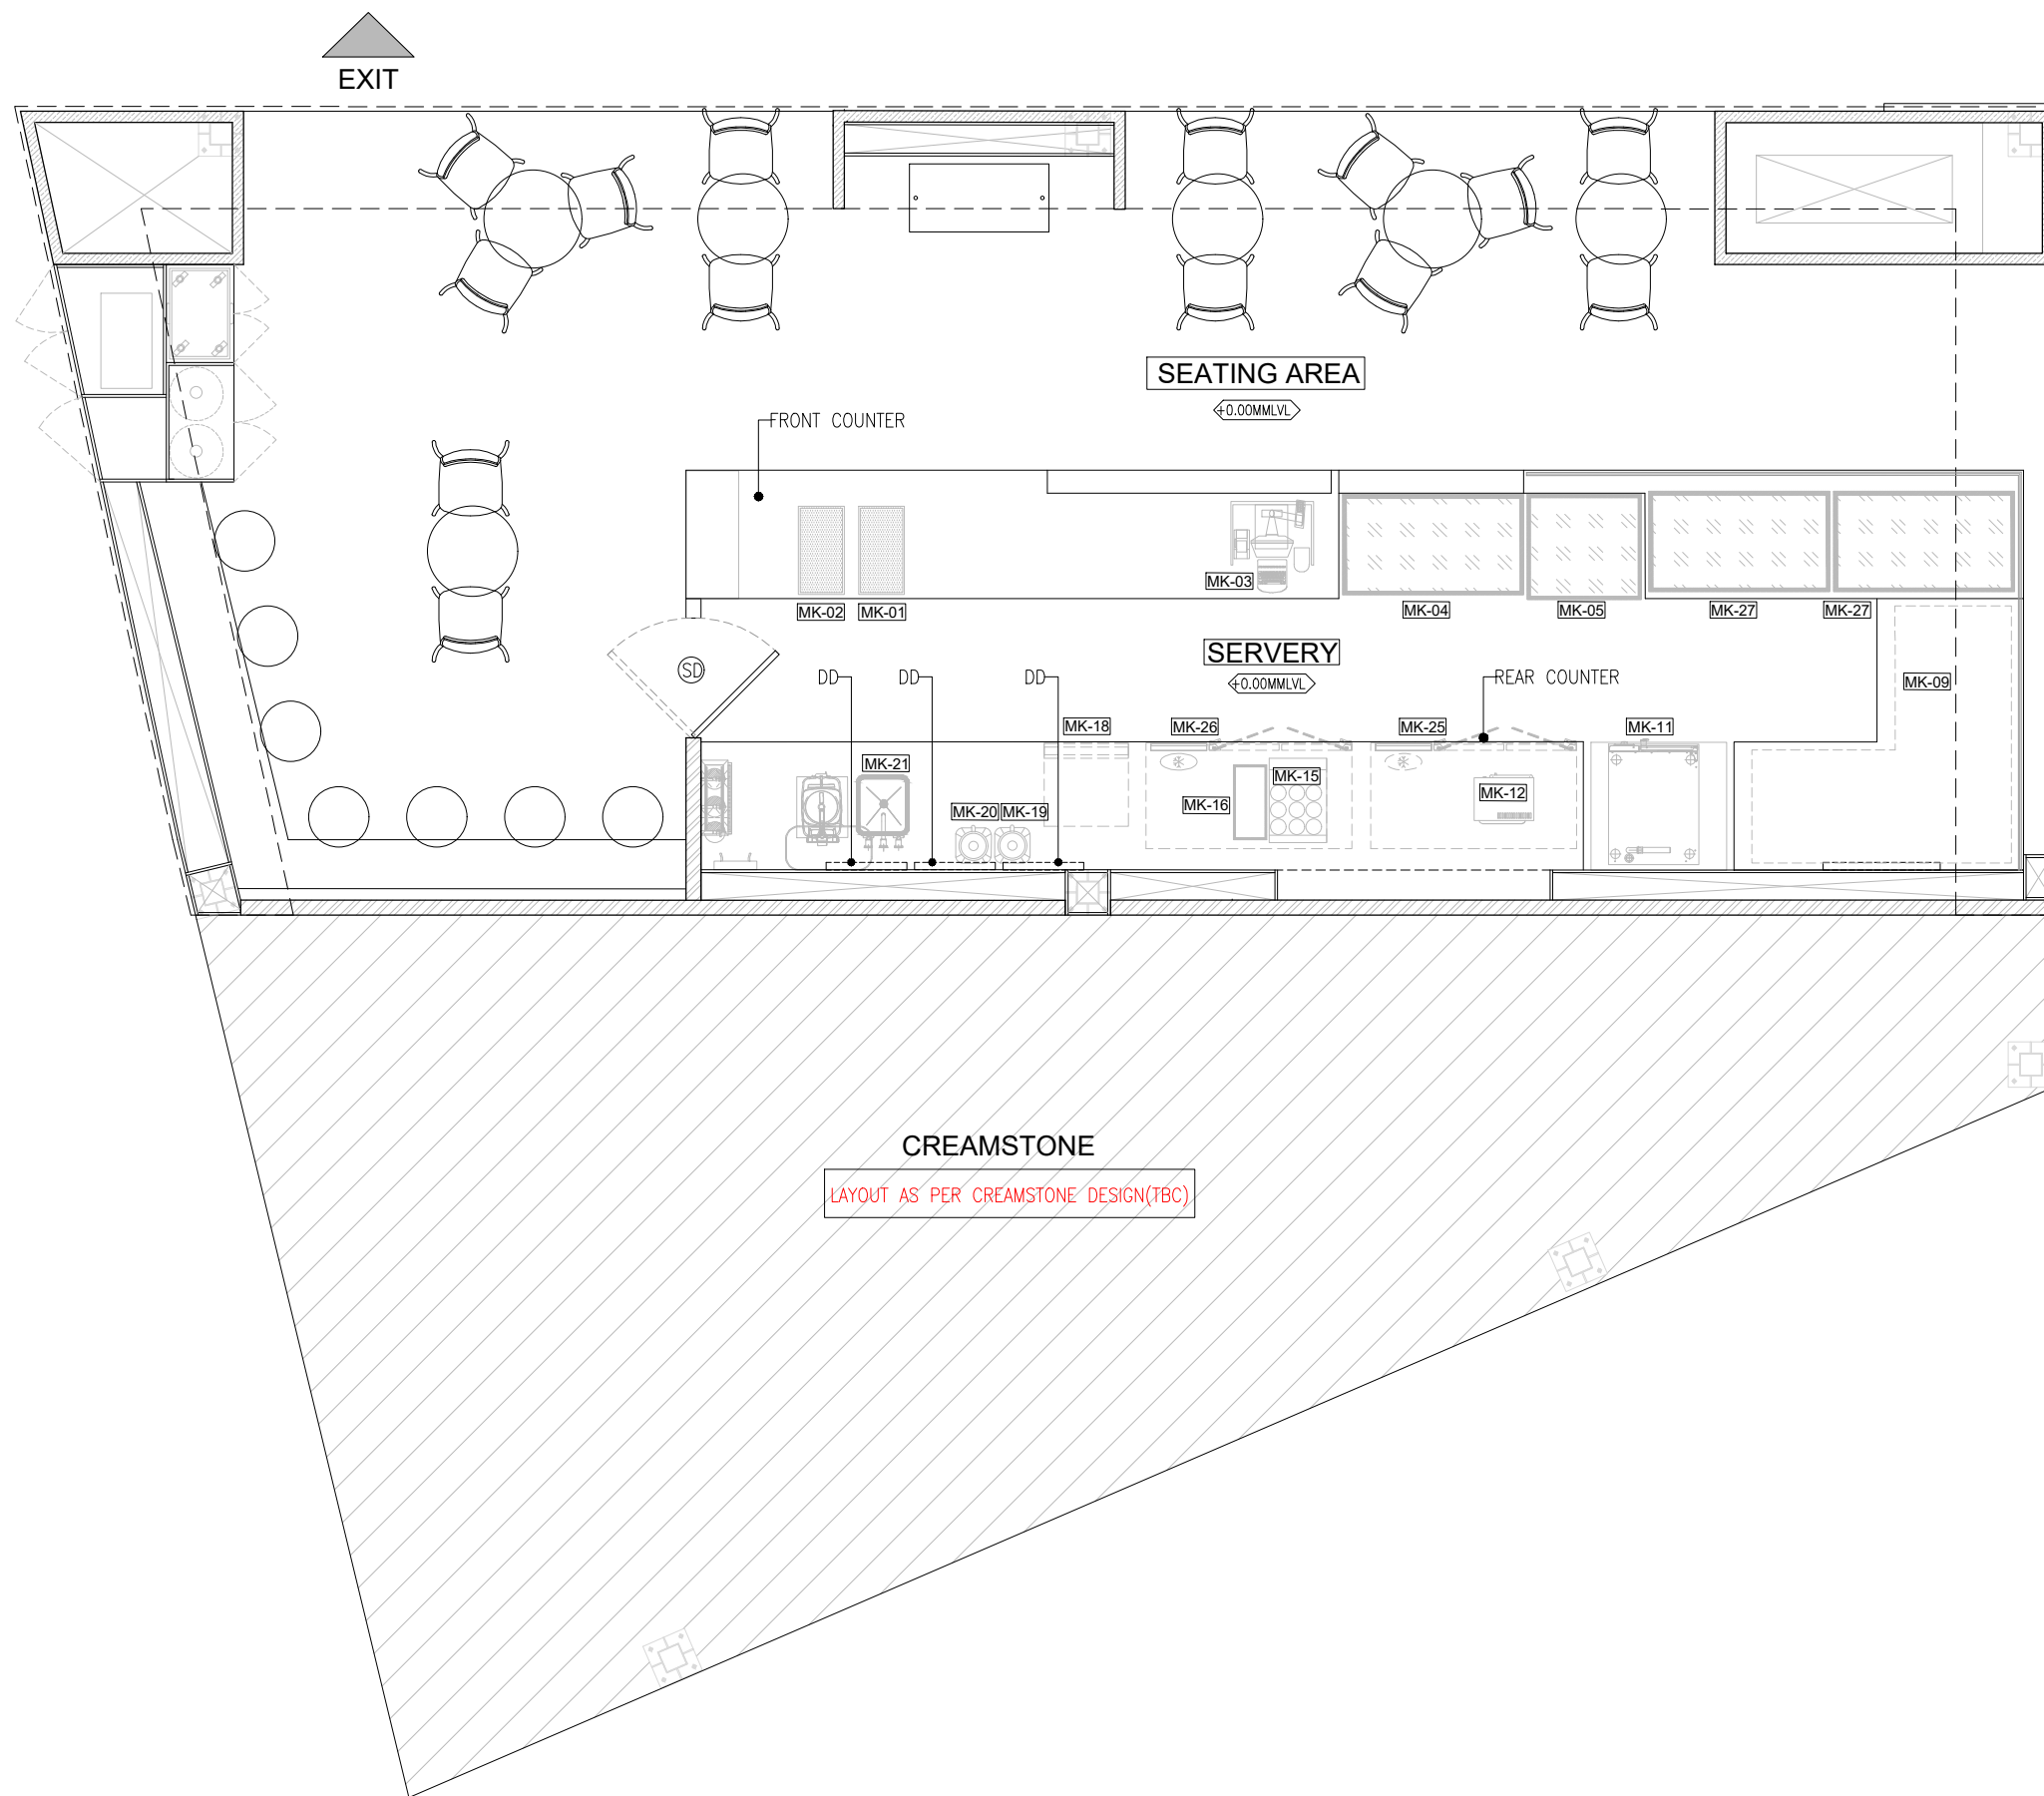

EQUIPMENT SCHEDULE			
CODE	DESCRIPTION	DIMENSION (All Dimensions in MM)(L x W x H)	COUNT
MK - 01	DRY GARBAGE BIN	584 x 304 x 765	1
MK - 02	WET GARBAGE BIN	584 x 304 x 765	1
MK - 03	POS WITH PRINTER		1
MK - 04	COLD DISPLAY COUNTER	1200 x 665 x 1235	1
MK - 05	ICE CREAM FRIDGE	756 x 695 x 885	1
MK - 09	COOKIE DECORATION TABLE WITH SNEEZE GUARD	1850 x 850 x 850 + 450	1
MK - 11	BAKERLUX SPEED.PRO™	600 x 797 x 541	1
MK - 12	MICROWAVE OVEN	511 x 311 x 432	1
MK - 15	COFFEE MACHINE	380 x 560 x 690	1
MK - 16	MILK FRIDGE	228 x 469 x 344	1
MK - 18	UNDER COUNTER ICE CUBE MACHINE	550 x 550 x 800	1
MK - 19	BLENDER	240 x 250 x 460	1
MK - 20	BLENDER	240 x 250 x 460	1
MK - 21	COUNTER MODEL SINK	500 x 432 x 210 DEEP	1
MK - 24	WATER BOILER (GEYSER)	15 LITRE.CAPACITY	1
MK - 25	TWO DOOR UNDER COUNTER REFRIGERATOR		1
MK - 26	TWO DOOR UNDER COUNTER FREEZER		1
MK - 27	COOKIE DISPLAY		2

REV	DATE	DESCRIPTION	HOD	CHK
C01	01.03.24	GOOD FOR CONSTRUCTION		NM



PROJECT
FF-025
MILIE COOKIES
HYDERABAD AIRPORT


DRAWING TITLE
EQUIPMENT LAYOUT

01 EQUIPMENT LAYOUT
02GA-101 1:50

SCALE 1:50 DATE 01.03.2024 DRAWN HOD A3 SHEET

STATUS
GOOD FOR CONSTRUCTION

ORG	PROJECT NO	DRAWING TYPE	NUMBER	REV
TFS	XXXX	02GA	101	C01

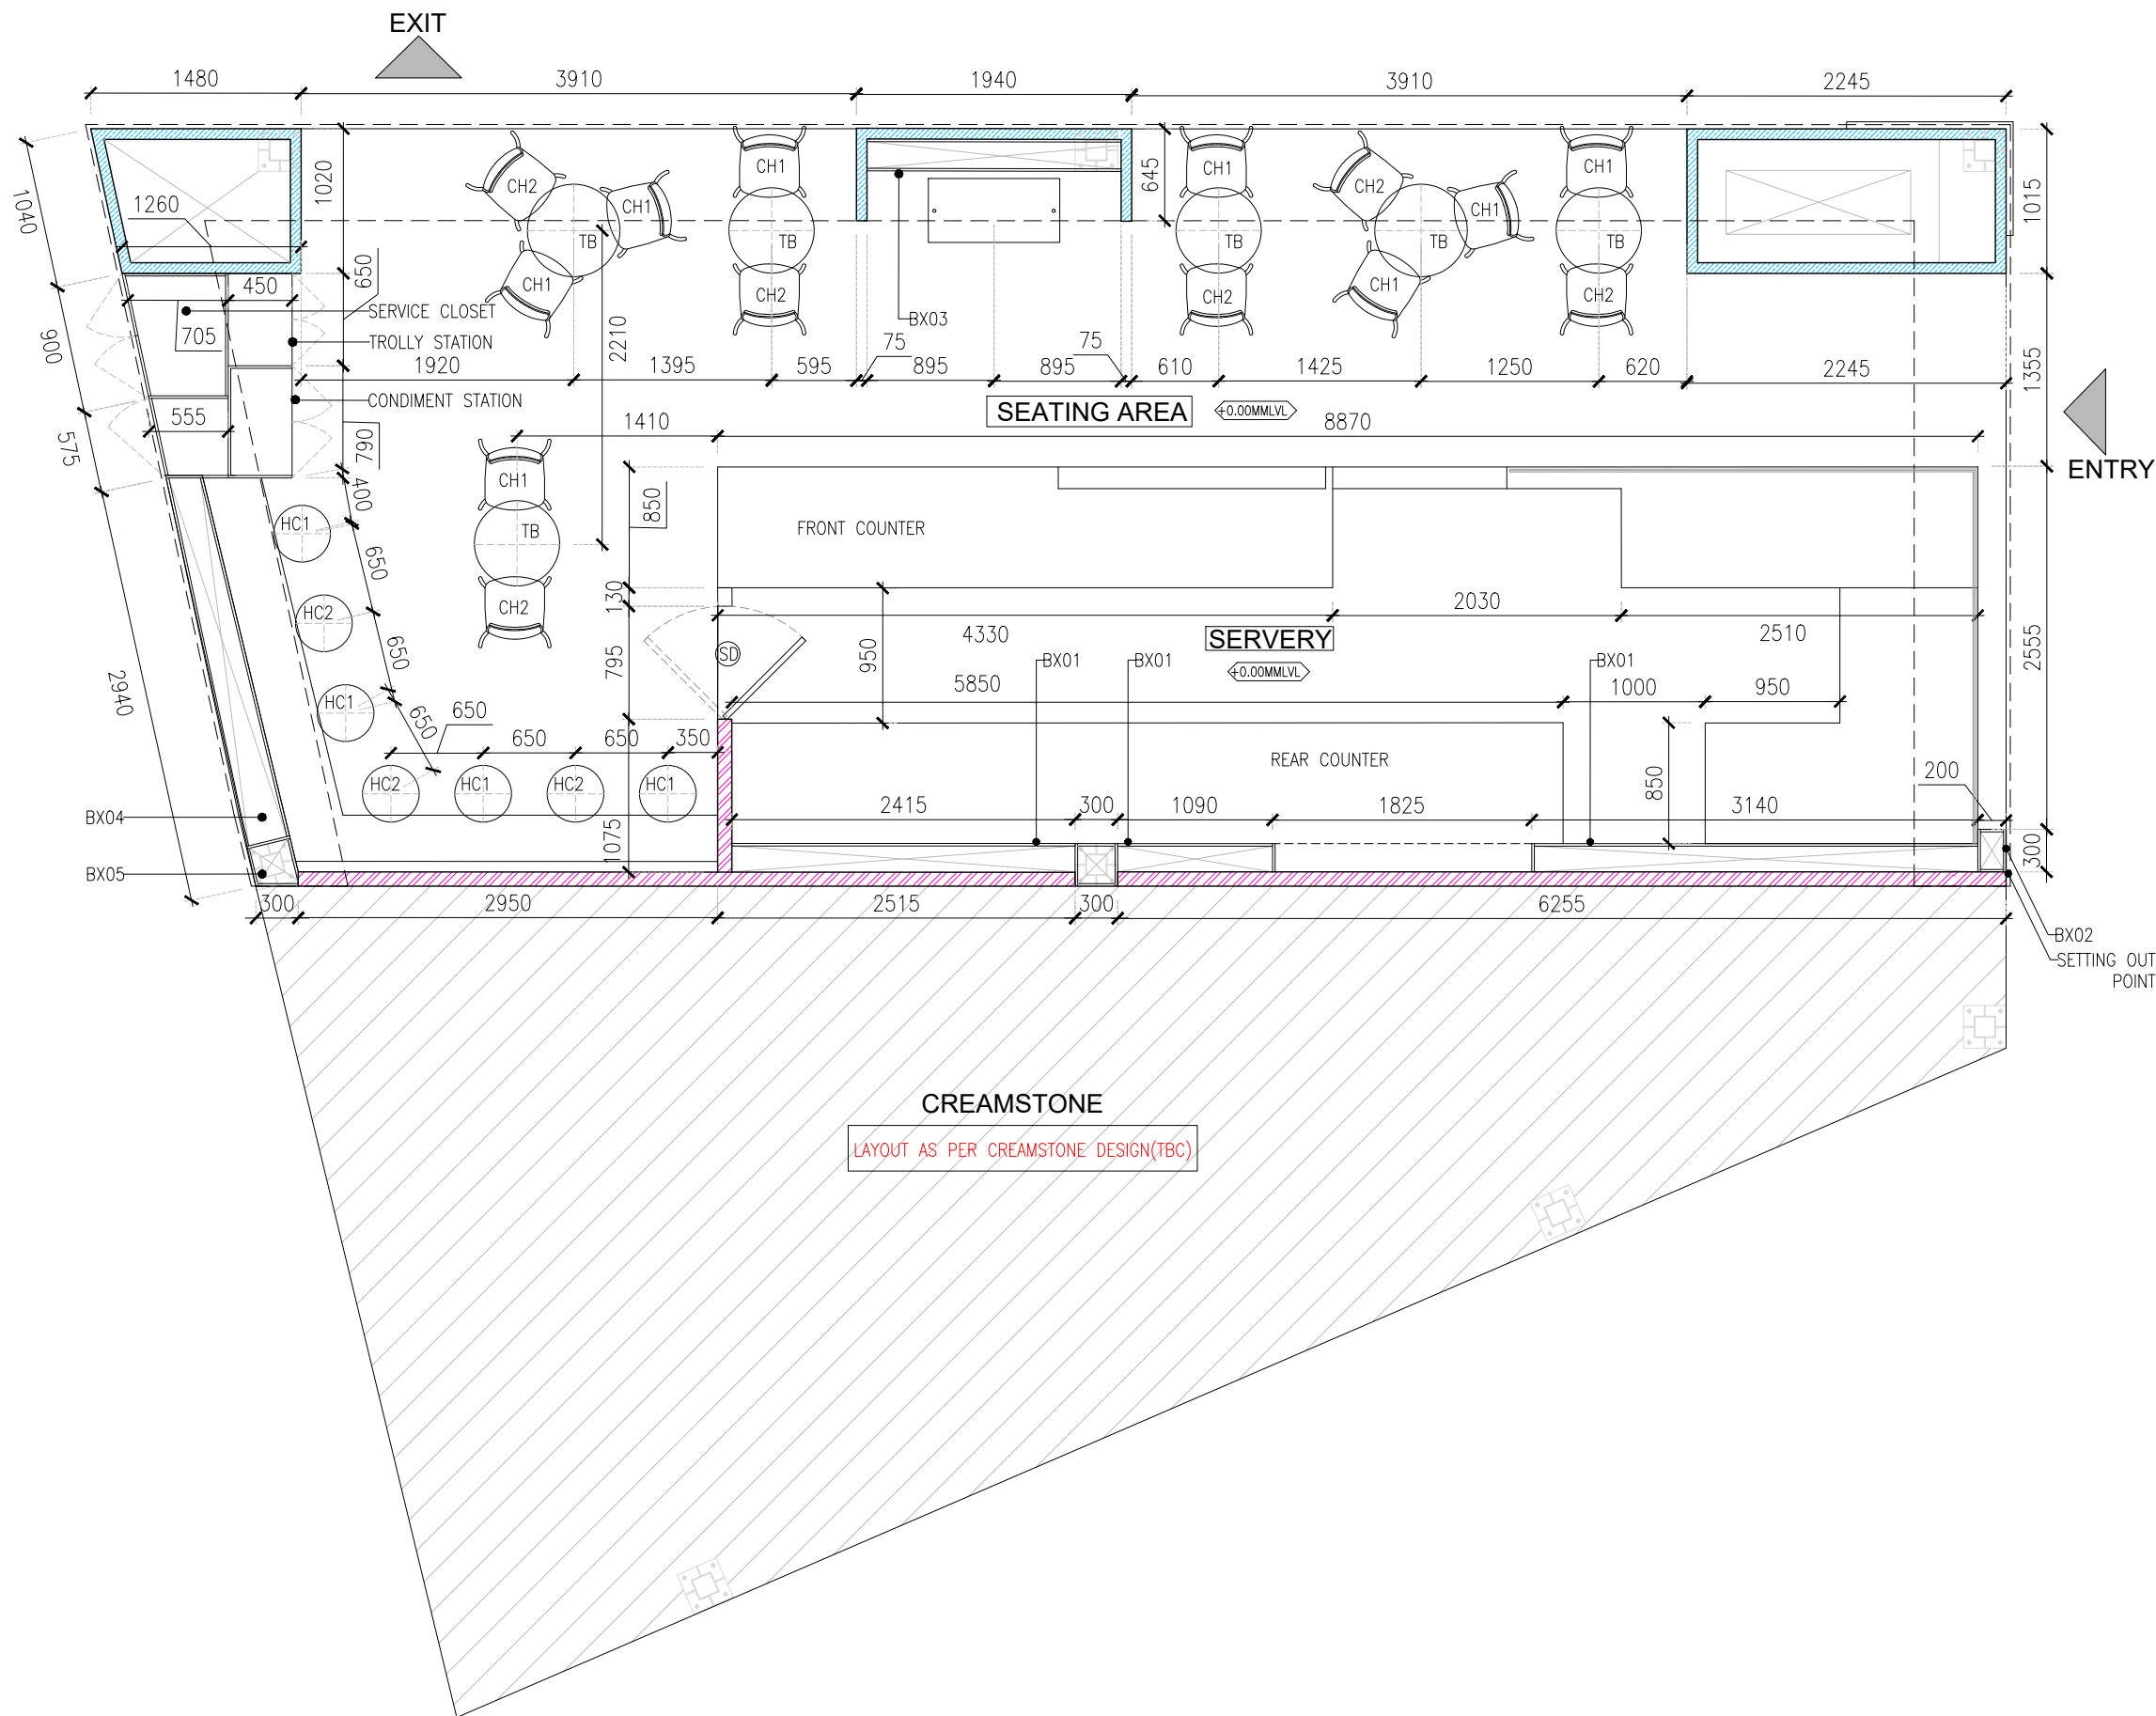

WALL LEGEND		
PATTERN	TYPE	HEIGHT
	PROPOSED 100MM THK DRY PARTITION WALL	+3000 MM
	PROPOSED 75MM THK LOW HEIGHT MASONRY WALL	+3000MM

BOX LEGEND			
CODE	NAME	SIZE(MM)	HEIGHT
BX01	BOX-01	AS PER DWG	+3000MM
BX02	BOX-02	AS PER DWG	+3000MM
BX03	BOX-03	AS PER DWG	+3000MM
BX04	BOX-04	AS PER DWG	+1100MM
BX05	BOX-05	AS PER DWG	+3000MM

FURNITURE LEGEND		
CODE	DESCRIPTION	COUNT
TB	DINING TABLE	06
CH1	DINING CHAIR-01	08
CH2	DINING CHAIR-02	06
HC1	HIGH CHAIR-01	04
HC1	HIGH CHAIR-01	03
TOTAL		21

REV	DATE	DESCRIPTION	HOD	DRN	CHK
C01	01.03.24	GOOD FOR CONSTRUCTION			



PROJECT
FF-025
MILIE COOKIES
HYDERABAD AIRPORT


DRAWING TITLE
SETTING OUT PLAN

01 SETTING OUT PLAN
02GA-102 1:50

SCALE 1:50 DATE 01.03.2024 DRAWN HOD A3 SHEET

STATUS
GOOD FOR CONSTRUCTION

ORG	PROJECT NO	DRAWING TYPE	NUMBER	REV
TFS	XXXX	02GA	102	C01

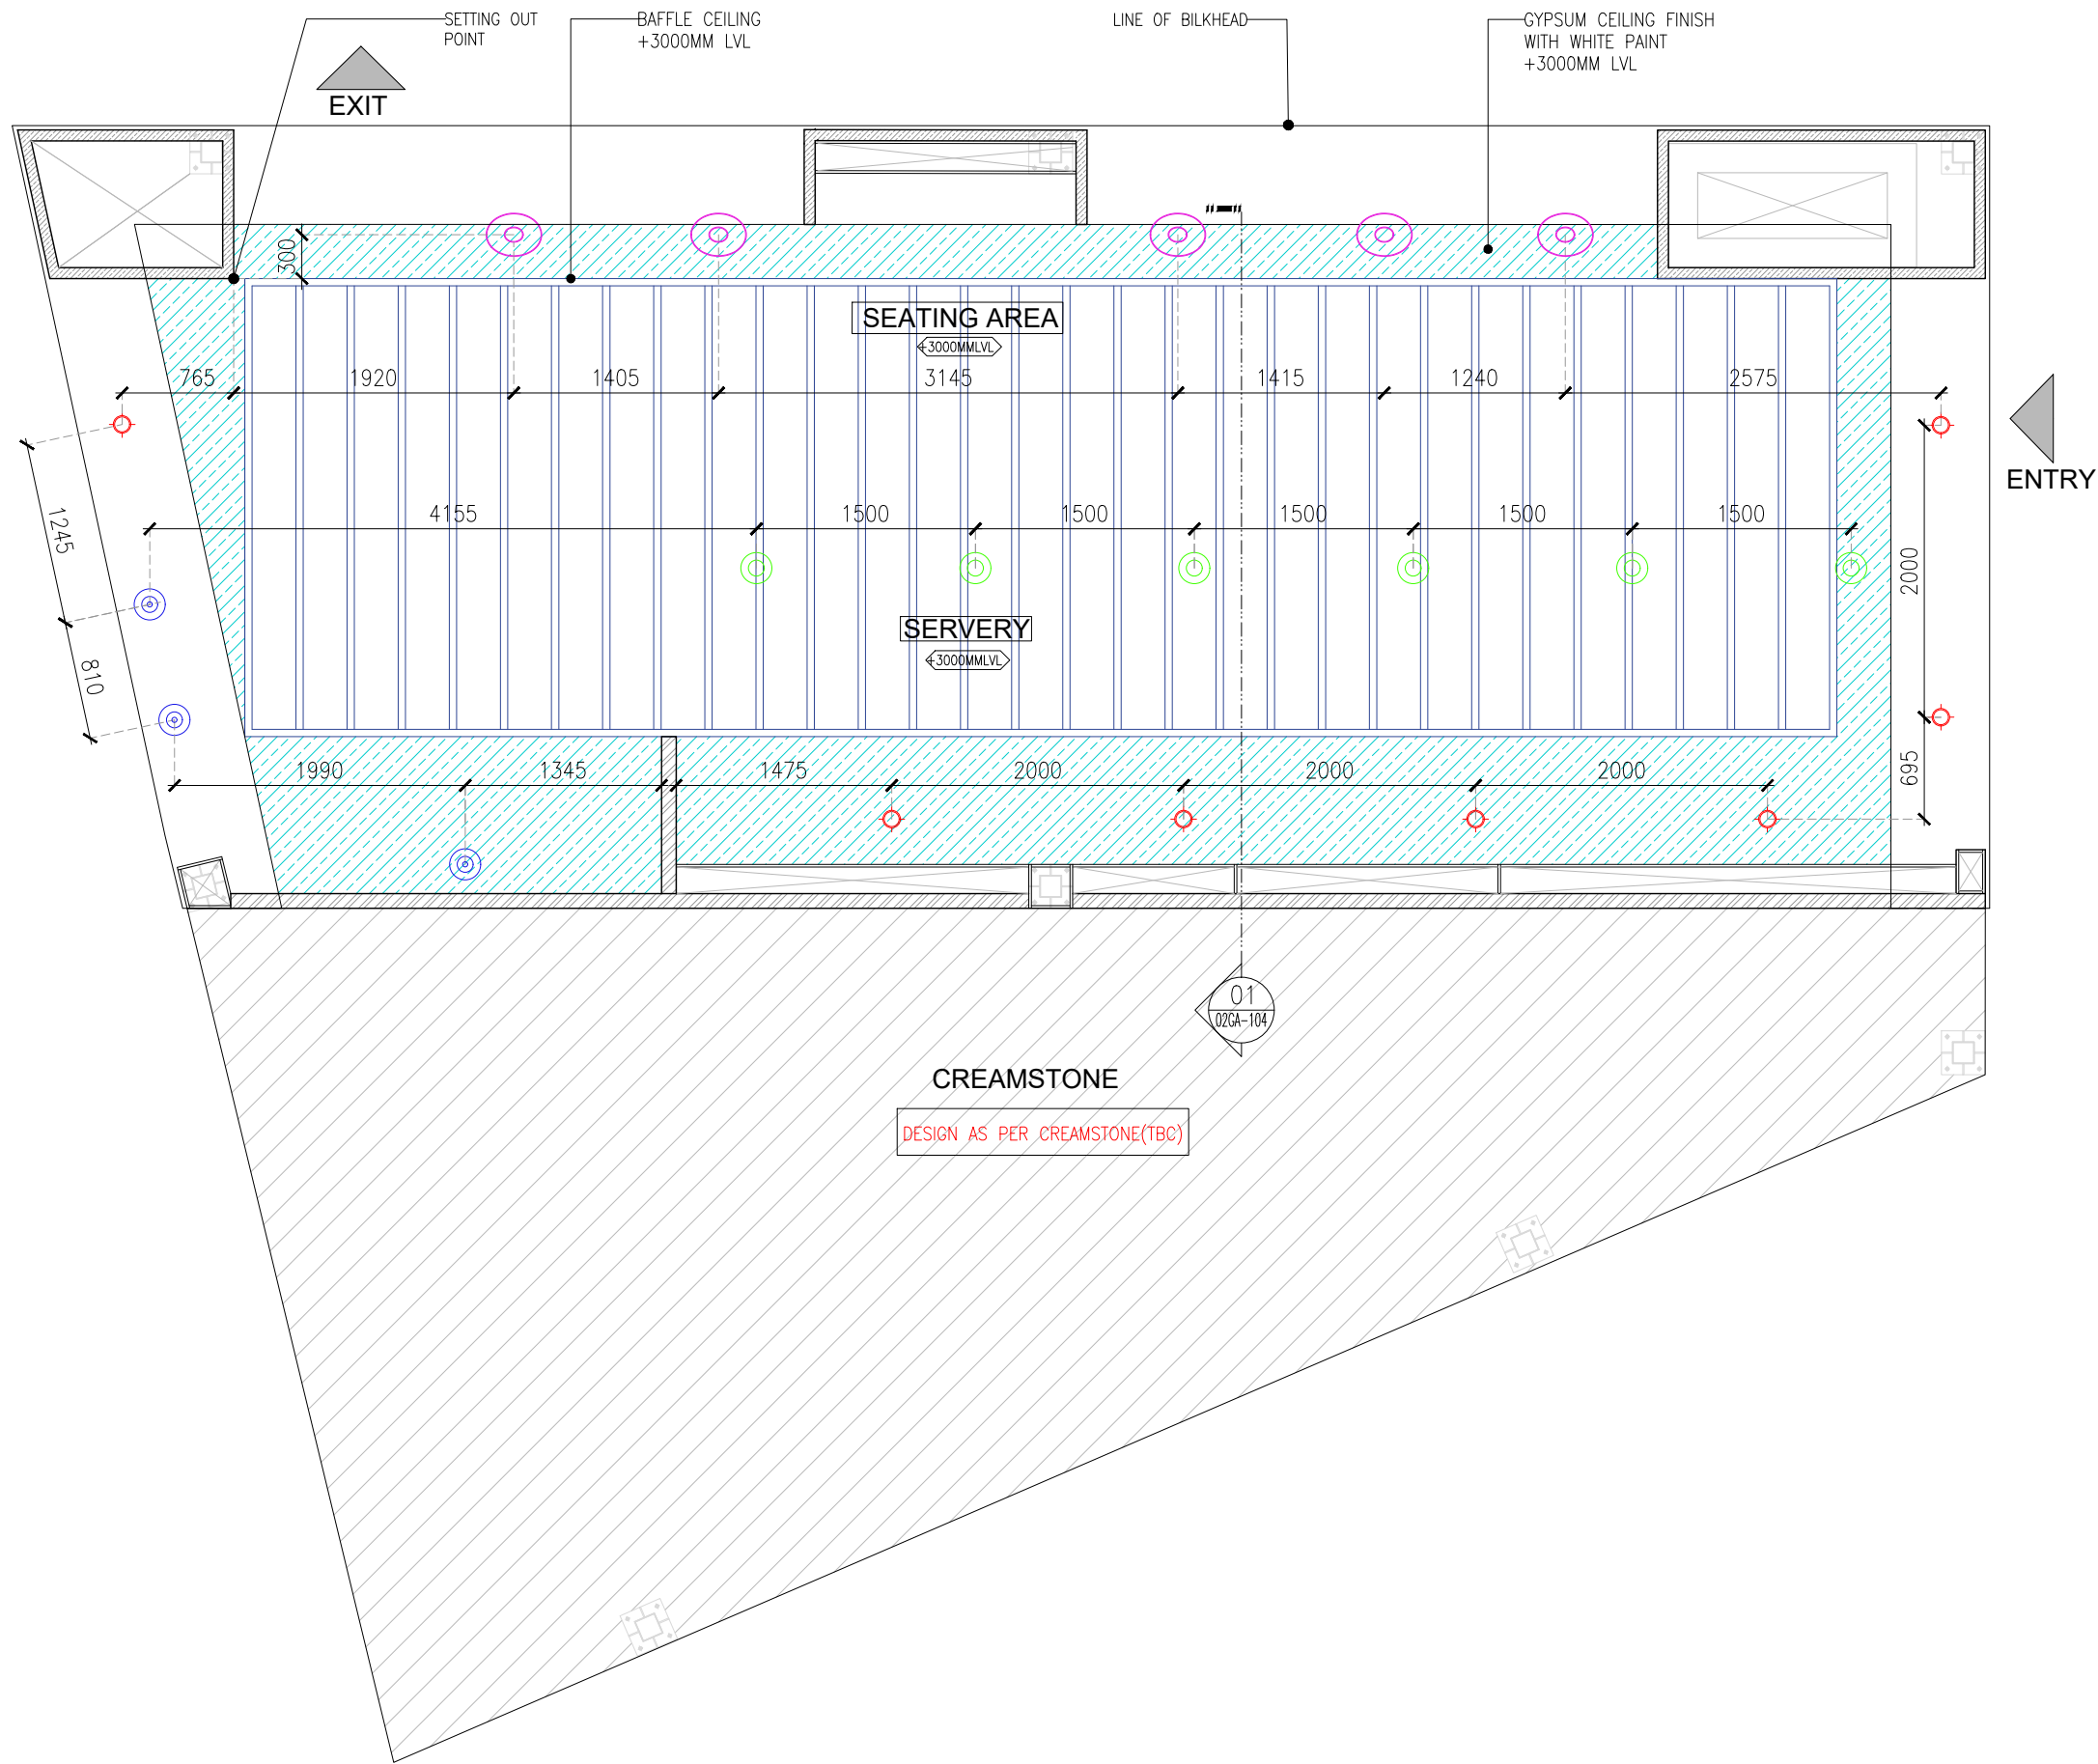

CEILING LEGEND			
PATTERN	TYPE	BOTTOM OF CEILING IN MM	AREA(M ²)
	GYPSUM CEILING	+3000MM	16.06
	BAFFLE CEILING	+3000MM	-

LIGHT FIXTURE LEGEND				
SYMBOL	TYPE	CODE	NOS.	IMAGE
	PENDANT LIGHT-01	LT01	05	
	PENDANT LIGHT-02	LT02	06	
	PENDANT LIGHT-03	LT03	03	
	RECESSED DOWN LIGHT	LT04	07	

01 RCP + LIGHTING LAYOUT :PART-A
02GA-103 1:50

C01	01.03.24	GOOD FOR CONSTRUCTION	HOD	NM
REV	DATE	DESCRIPTION	DRN	CHK




PROJECT
FF-025
MILIE COOKIES
HYDERABAD AIRPORT

DRAWING TITLE
RCP + LIGHTING LAYOUT :PART-A


SCALE 1:50 DATE 01.03.2024 DRAWN HOD A3 SHEET

STATUS
GOOD FOR CONSTRUCTION

ORG	PROJECT NO	DRAWING TYPE	NUMBER	REV
TFS	XXXX	02GA	103	C01

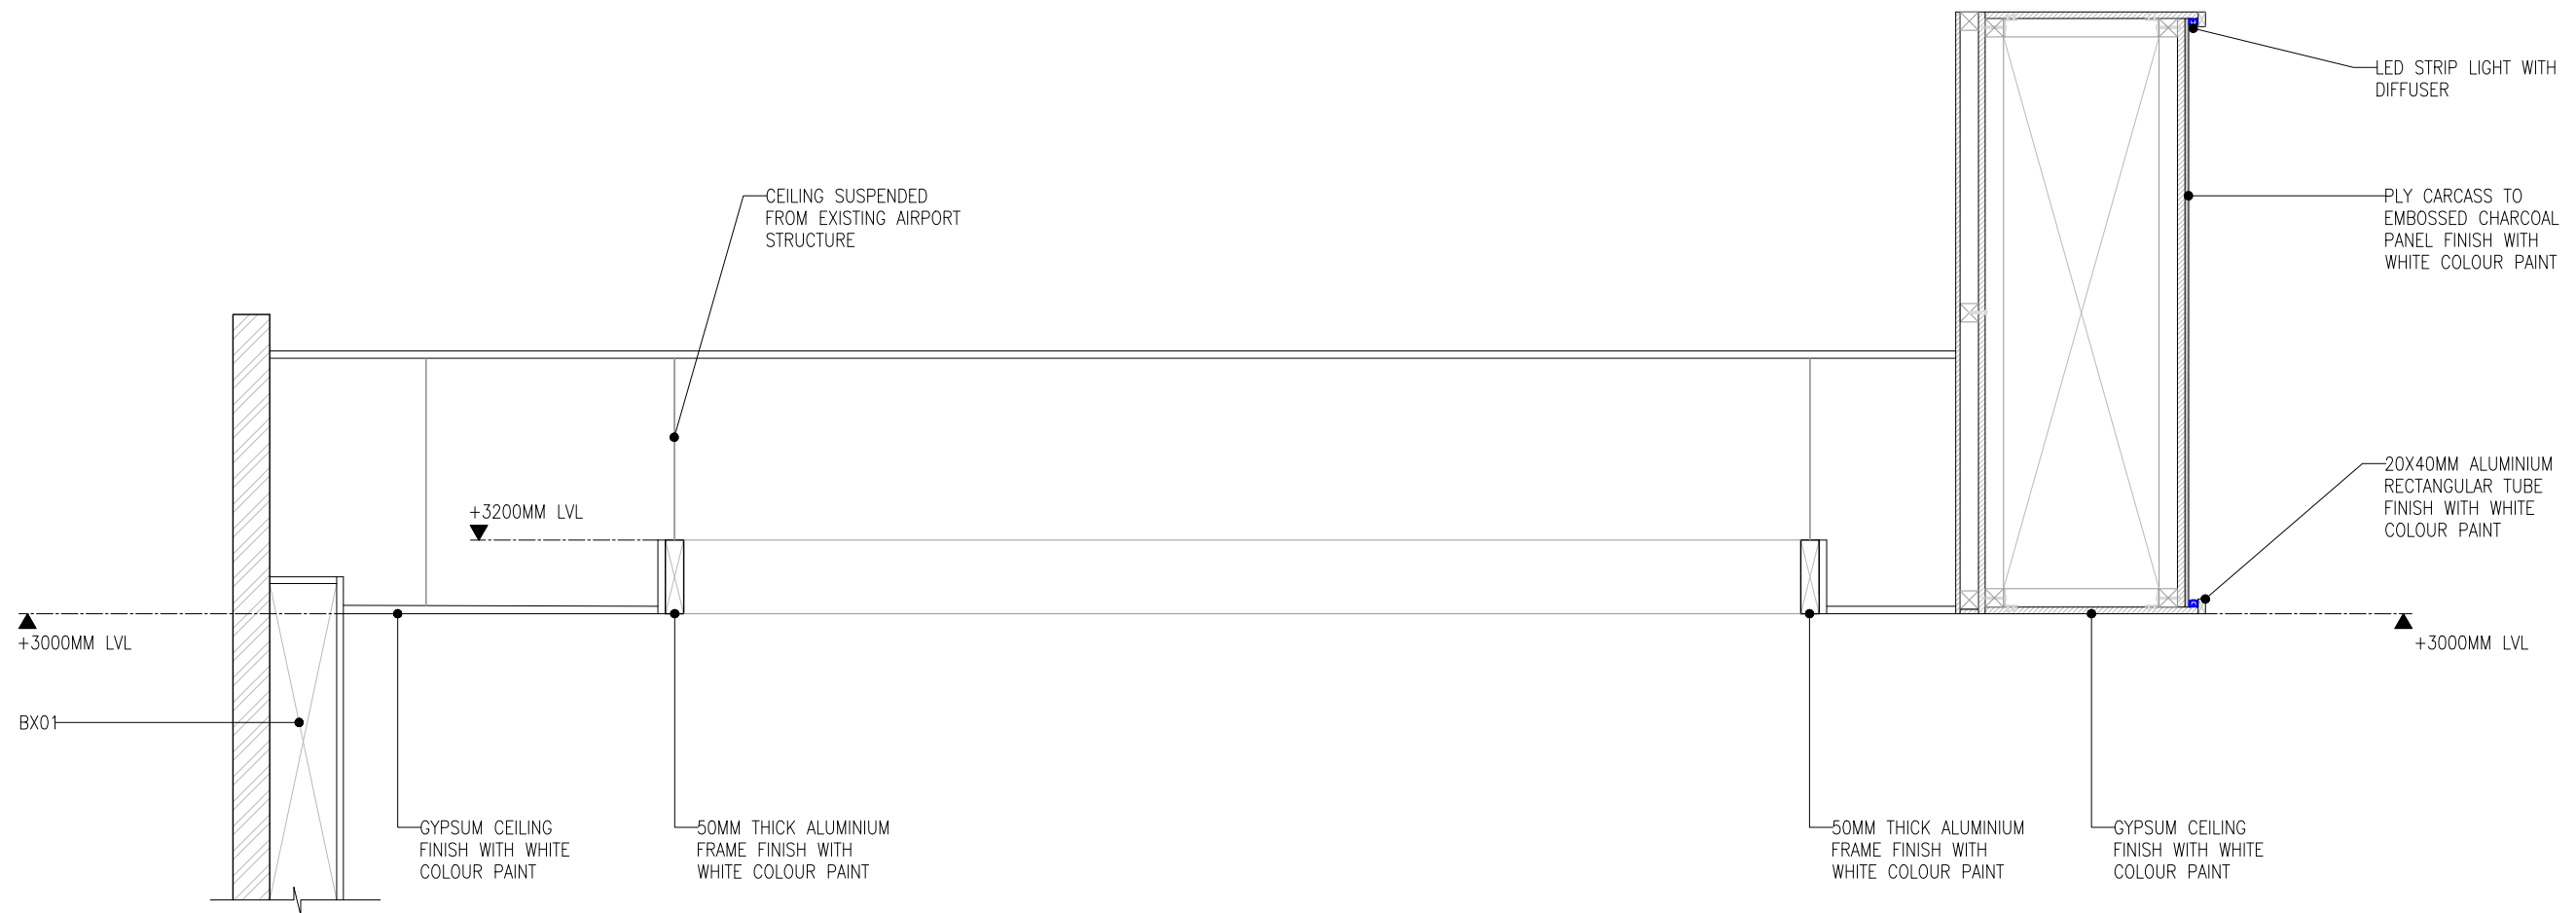

01 SECTION-01
02GA-104 1:20

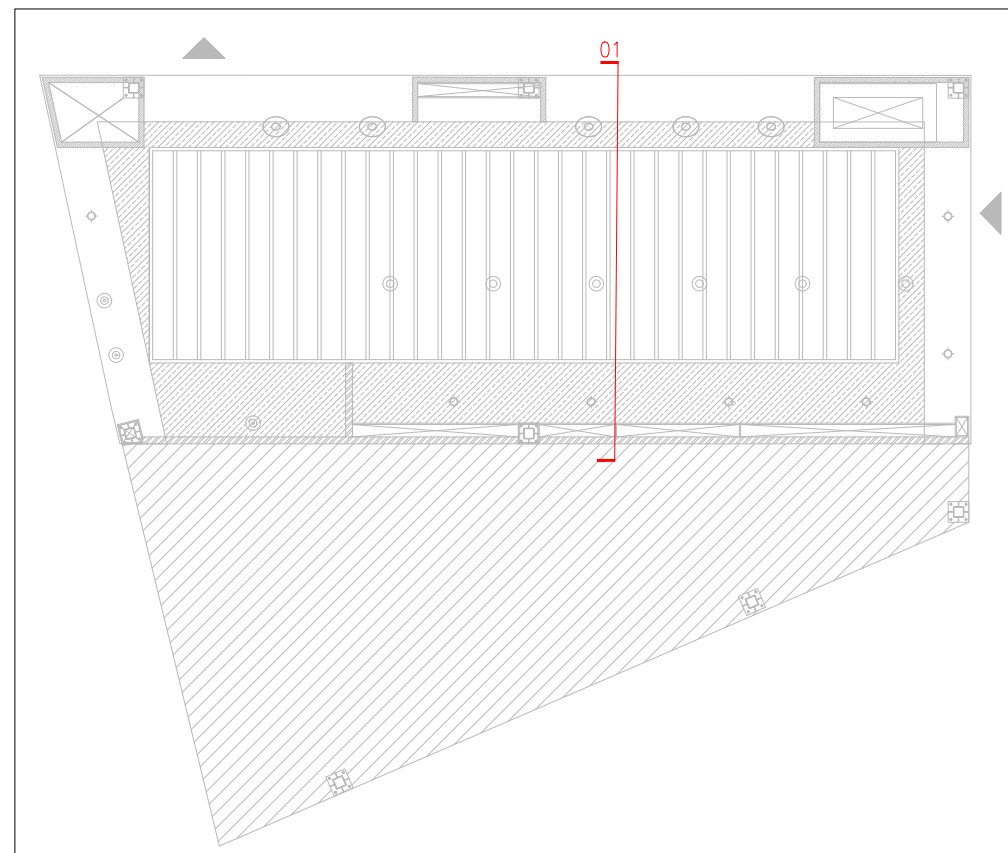

KEY PLAN

C01	01.03.24	GOOD FOR CONSTRUCTION	HOD	NM
REV	DATE	DESCRIPTION	DRN	CHK




PROJECT
FF-025
MILIE COOKIES
HYDERABAD AIRPORT

DRAWING TITLE
RCP + LIGHTING LAYOUT :PART-B


SCALE 1:20 DATE 01.03.2024 DRAWN HOD A3 SHEET

STATUS
GOOD FOR CONSTRUCTION

ORG	PROJECT NO	DRAWING TYPE	NUMBER	REV
TFS	XXXX	02GA	104	C01

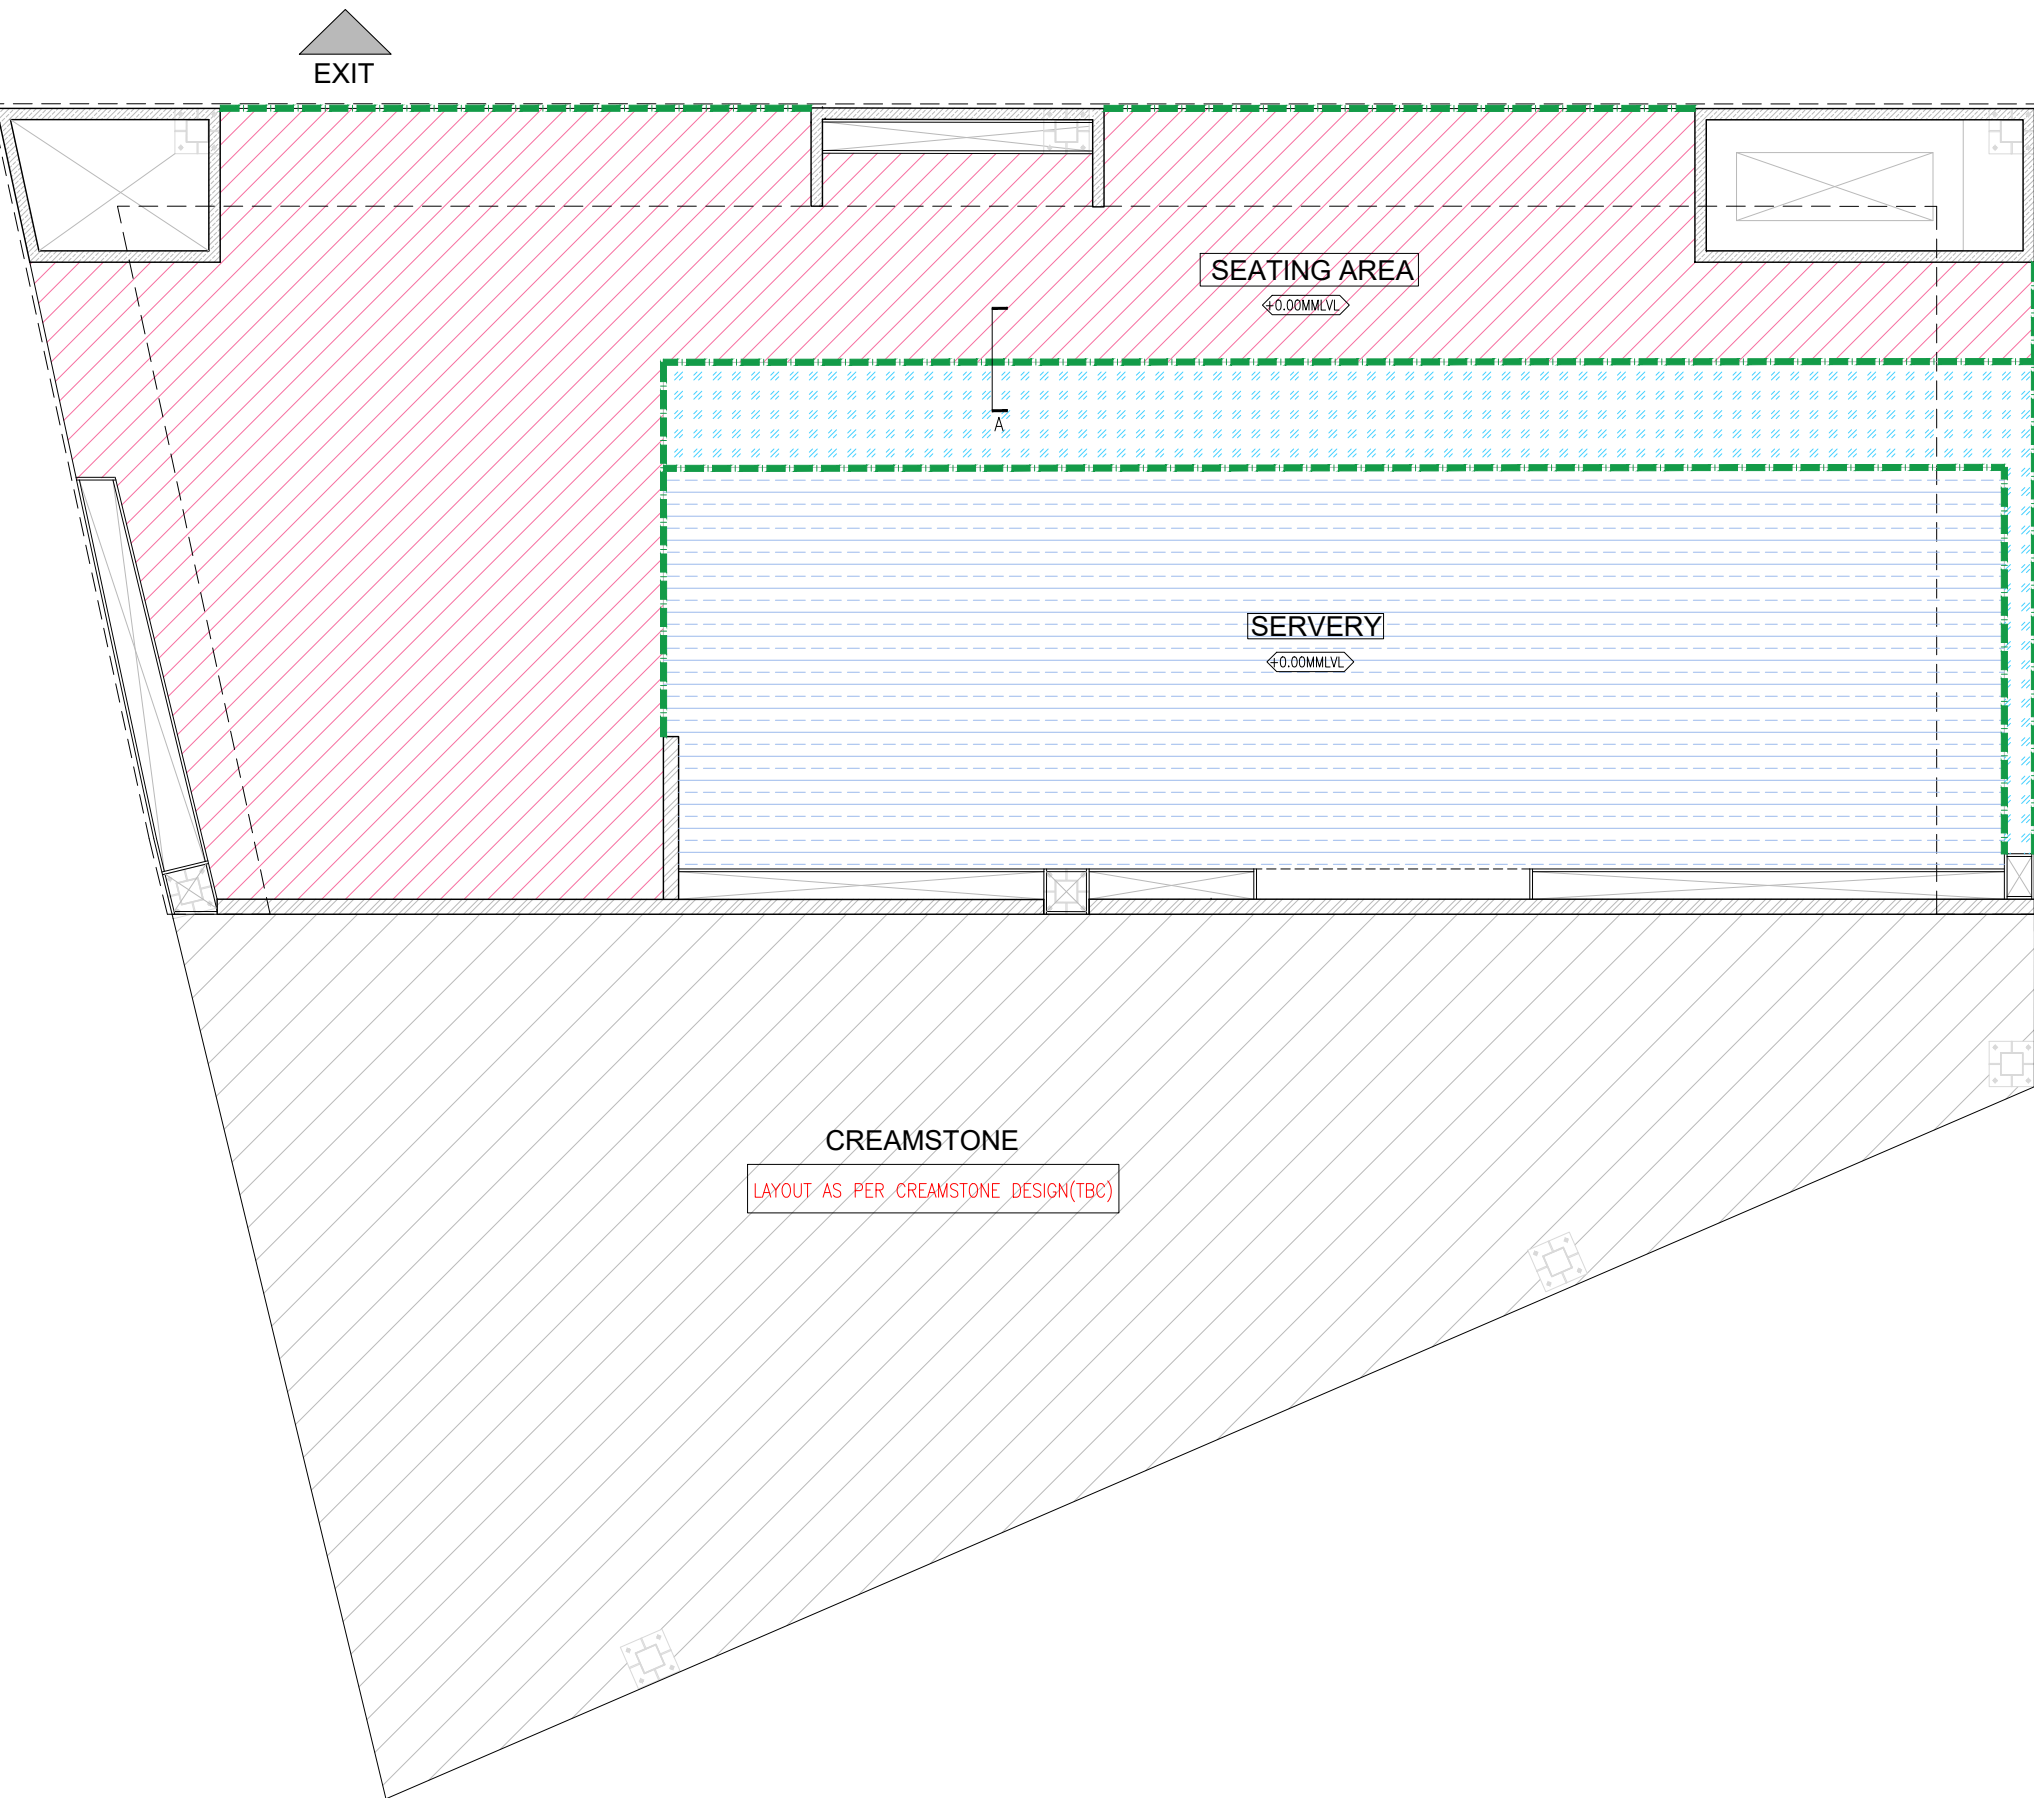

FLOORING LEGEND			
CODE	PATTERN	TYPE	AREA/LENGTH
FL01		POLISHED CONCRETE	30.06 M ²
FL02		300X300MM PATTERNED PORCELAIN TILE	6.88 M ²
FL03		600X600MM GREY COLOUR KOTA STONE	23.41M ²
FL04		S.S. 304 GRADE T-SHAPE TRANSITION TRIM	38.56M

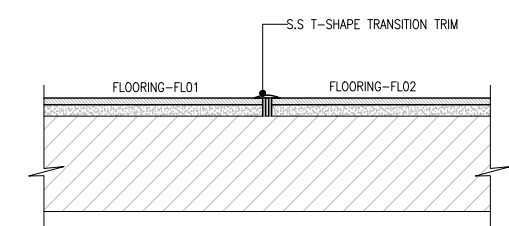

TYPICAL FLOOR TRANSITION DETAIL SECTION-A

C01	01.03.24	GOOD FOR CONSTRUCTION	HOD	NM
REV	DATE	DESCRIPTION	DRN	CHK



PROJECT
FF-025
MILIE COOKIES
HYDERABAD AIRPORT

DRAWING TITLE
FLOORING LAYOUT

01 FLOORING LAYOUT
02GA-105 1:50


SCALE	1:50	DATE	01.03.2024	DRAWN HOD	A3	SHEET
STATUS GOOD FOR CONSTRUCTION						
ORG	PROJECT NO	DRAWING TYPE	NUMBER	REV		
TFS	XXXX	02GA	105	C01		

ALL DIMENSIONS MUST BE CHECKED ON SITE
INFORM THE ARCHITECT OF ANY DISCREPANCIES PRIOR TO CONSTRUCTION

 WATER PROOFING AREA

TOTAL AREA TO BE WATER PROOFED= 24.33M²

EXIT 

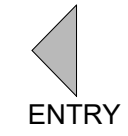
ENTRY 

SEATING AREA
+0.00MMLVL

SERVERY
+0.00MMLVL

CREAMSTONE

LAYOUT AS PER CREAMSTONE DESIGN(TBC)

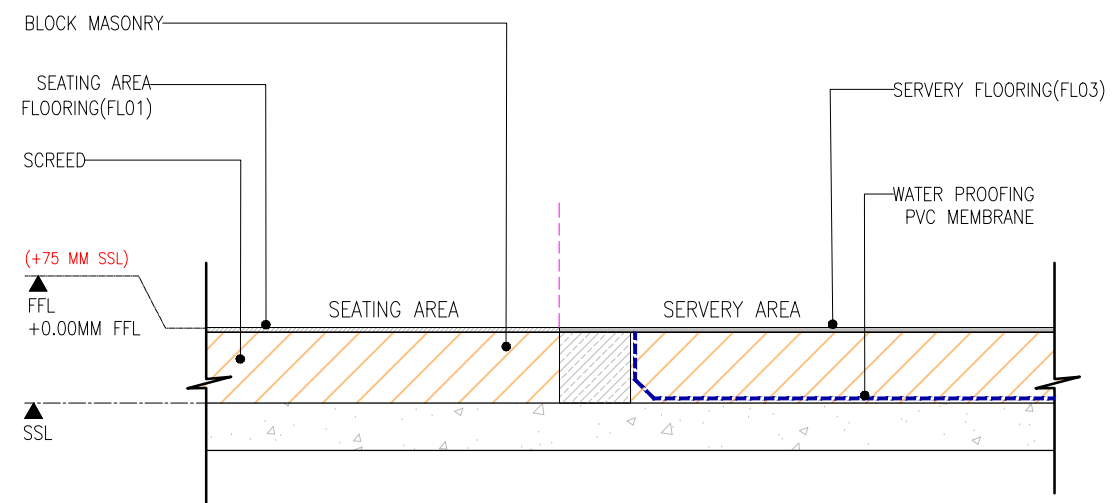

SECTION-A (SCALE 1:10)

01 WATER PROOFING LAYOUT
02GA-106 1:50

C01	01.03.24	GOOD FOR CONSTRUCTION	HOD	NM
REV	DATE	DESCRIPTION	DRN	CHK




PROJECT
FF-025
MILIE COOKIES
HYDERABAD AIRPORT

DRAWING TITLE
WATER PROOFING LAYOUT

SCALE 1:50 DATE 01.03.2024 DRAWN HOD A3 SHEET

STATUS
GOOD FOR CONSTRUCTION

ORG	PROJECT NO	DRAWING TYPE	NUMBER	REV
TFS	XXXX	02GA	106	C01

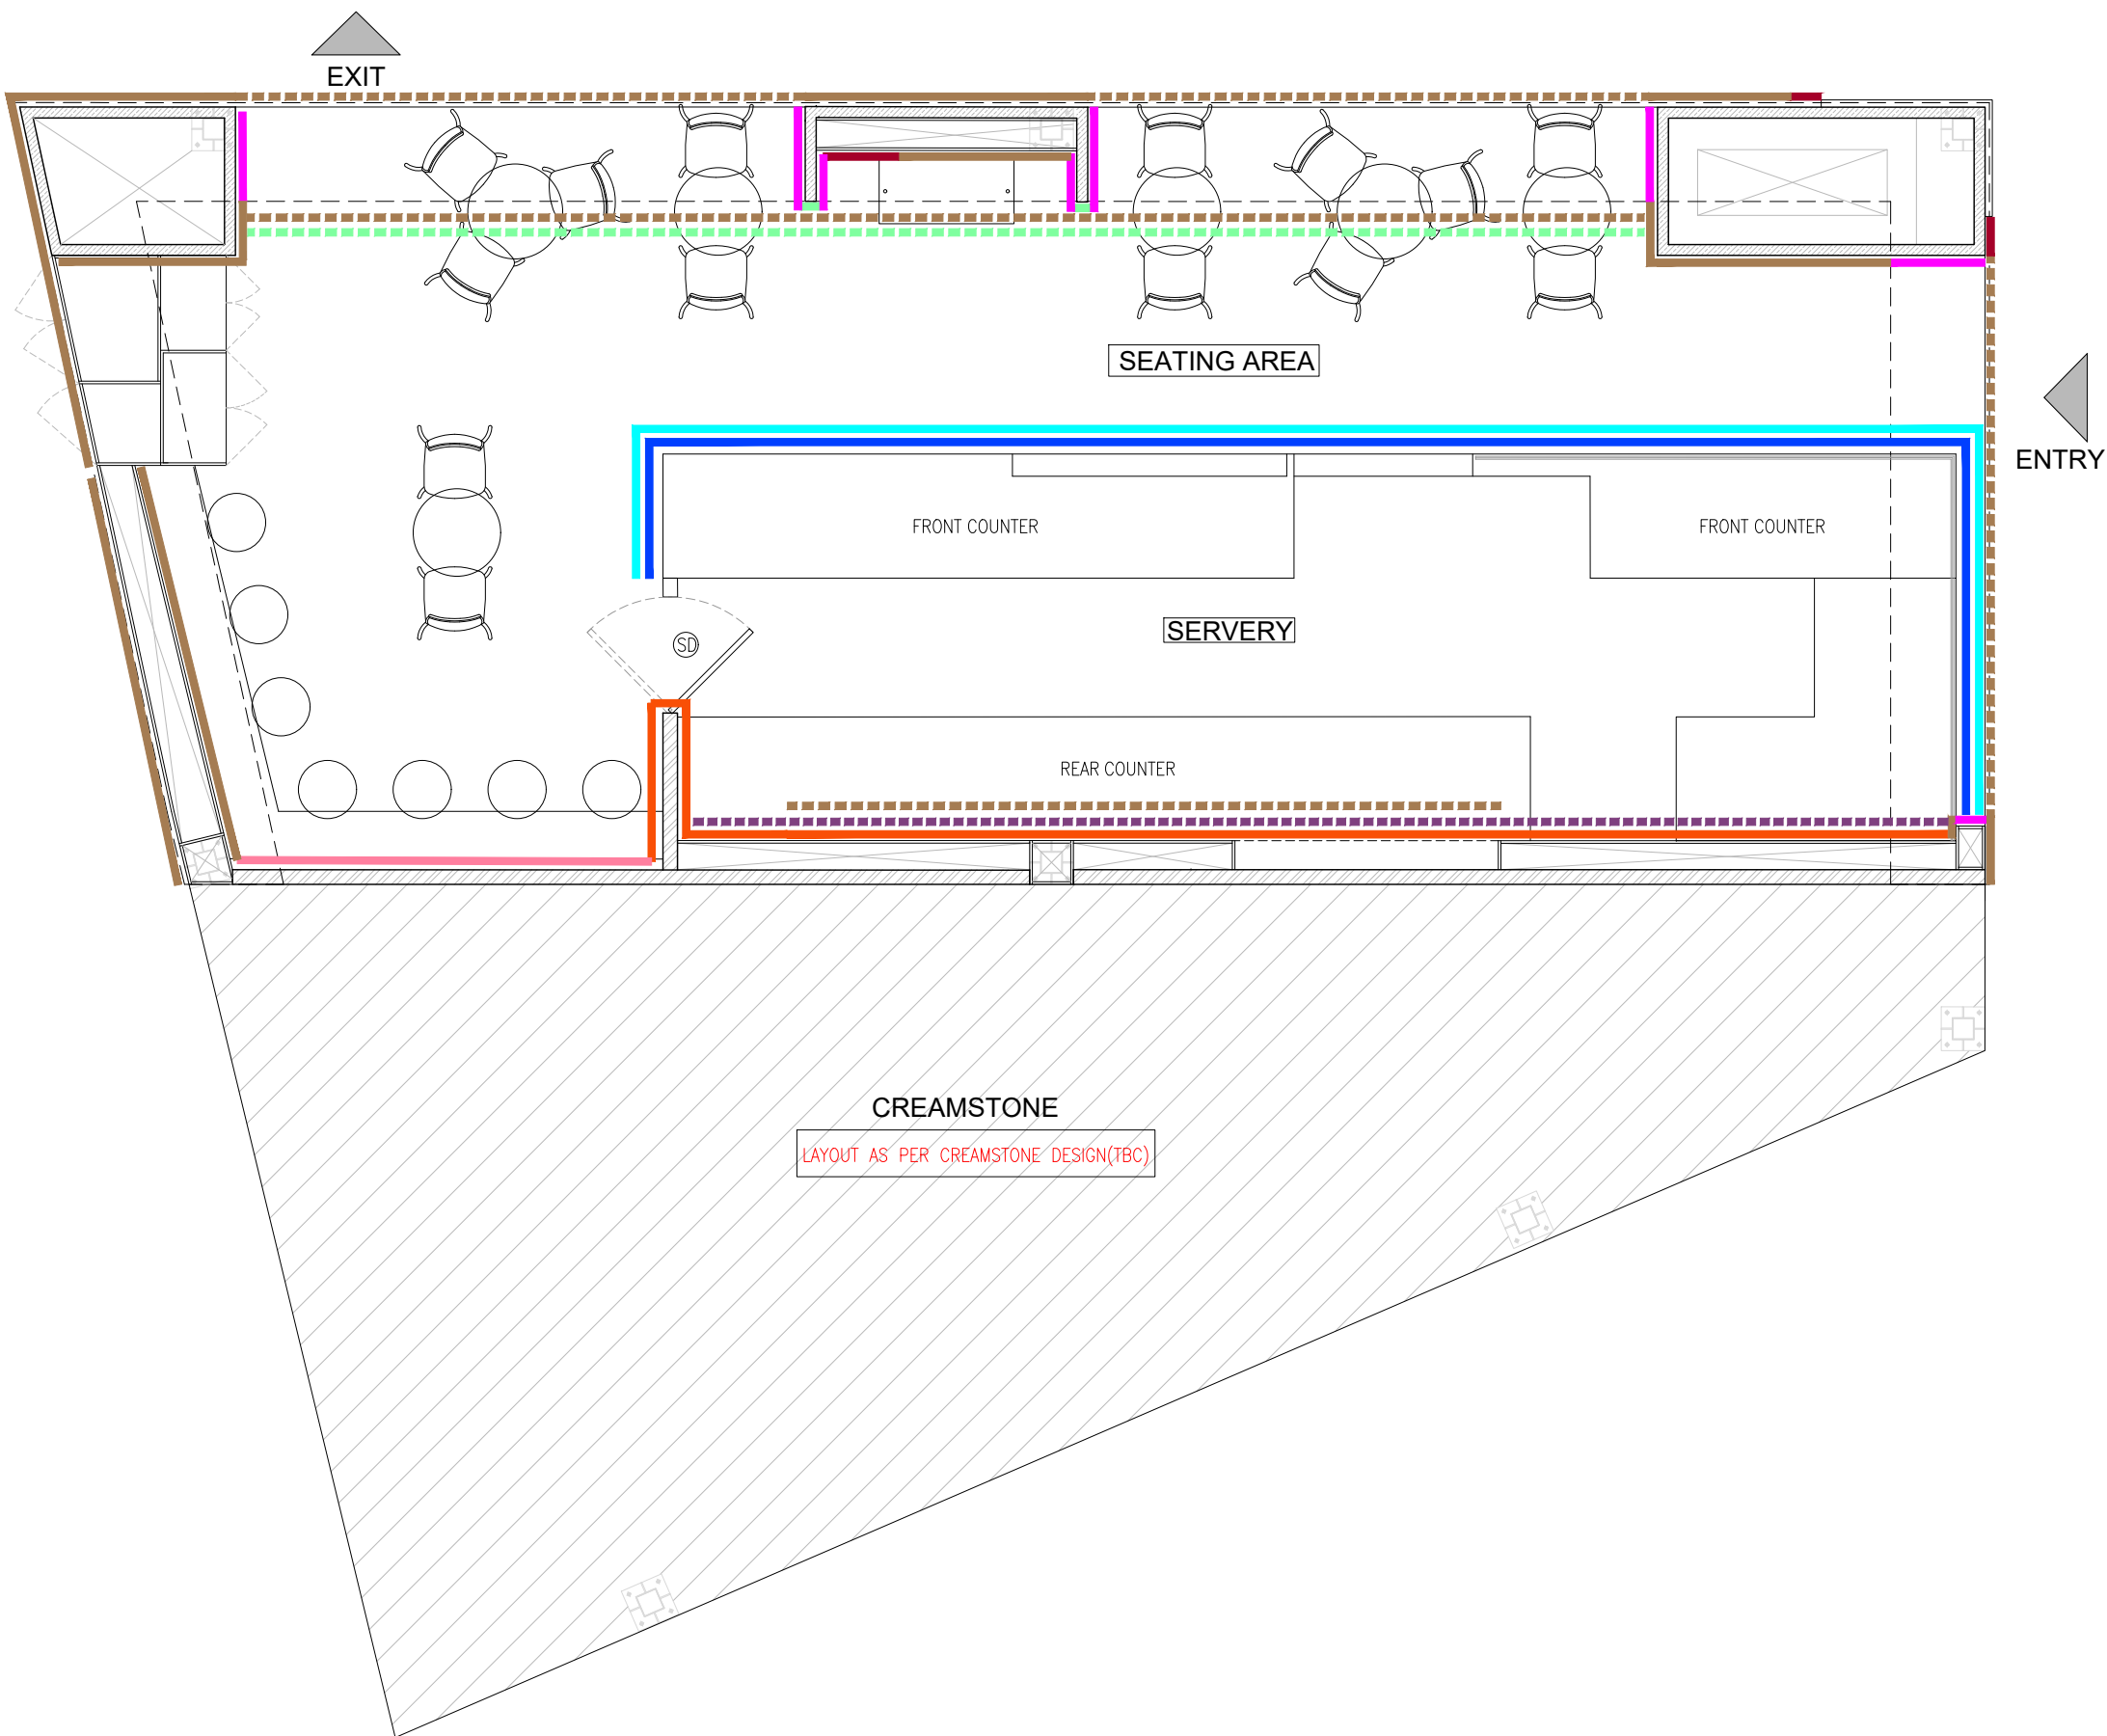

FINISHES LEGEND		
SYMBOL	FINISH	SURFACE
	PT01 WHITE COLOUR PAINT	FRONT COUNTER
	PT03 WHITE COLOUR LACQUER PAINT	WALL,BOX
	PT04 HEATHER VIOLET COLOUR PAINT RAL:4003	WALL,BOX
	PT05 PASTEL TURQUOISE COLOUR PAINT RAL:4003	WALL&MDF PANEL
	CP01 EMBOSSSED CHARCOAL PANEL FINISH WITH WHITE COLOUR PAINT(PT01)	FRONT COUNTER
	WT01 100X100MM PASTEL TURQUOISE COLOUR CERAMIC TILE WITH WHITE GROUT	WALL & BOX
	WT02 100X100MM HEATHER VIOLET COLOUR CERAMIC TILE WITH WHITE GROUT	WALL & BOX
	GL01 8MM THK FLUTED GLASS	BOX
	GR01 VINYL STICKER	WALL& BULKHEAD

REV	DATE	DESCRIPTION	HOD	NM	DRN	CHK
C01	01.03.24	GOOD FOR CONSTRUCTION				



PROJECT
FF-025
MILIE COOKIES
HYDERABAD AIRPORT



DRAWING TITLE
FINISHES PLAN

01 FINISHES PLAN
02GA-108 1:50

SCALE 1:50 DATE 01.03.2024 DRAWN HOD A3 SHEET

STATUS
GOOD FOR CONSTRUCTION

ORG	PROJECT NO	DRAWING TYPE	NUMBER	REV
TFS	XXXX	02GA	107	C01

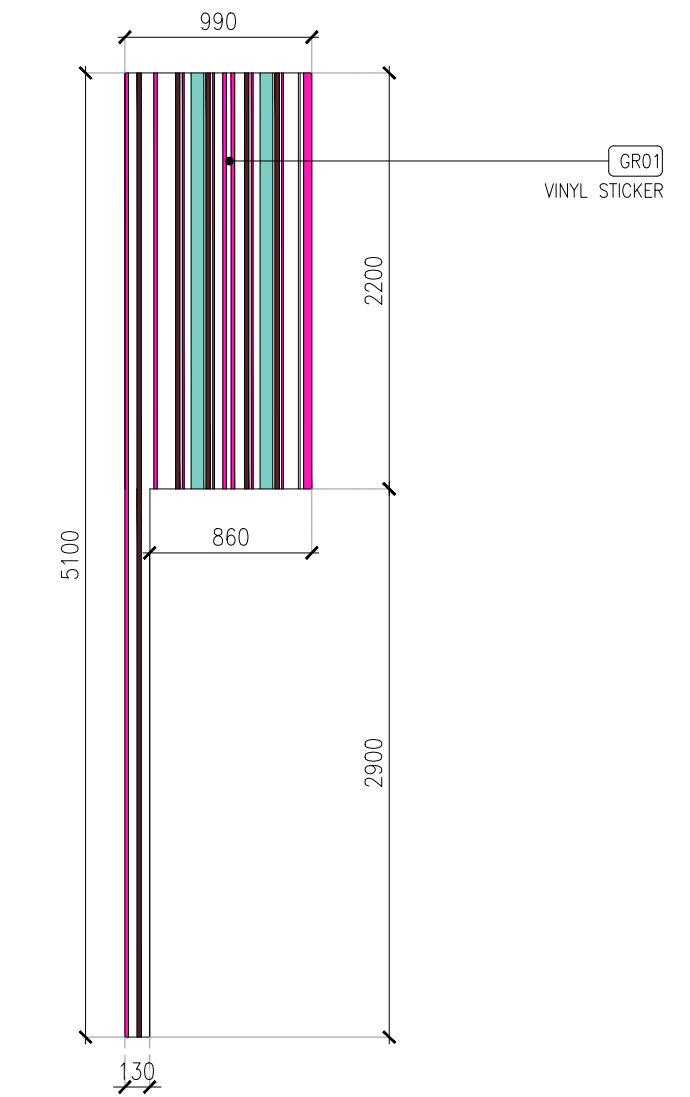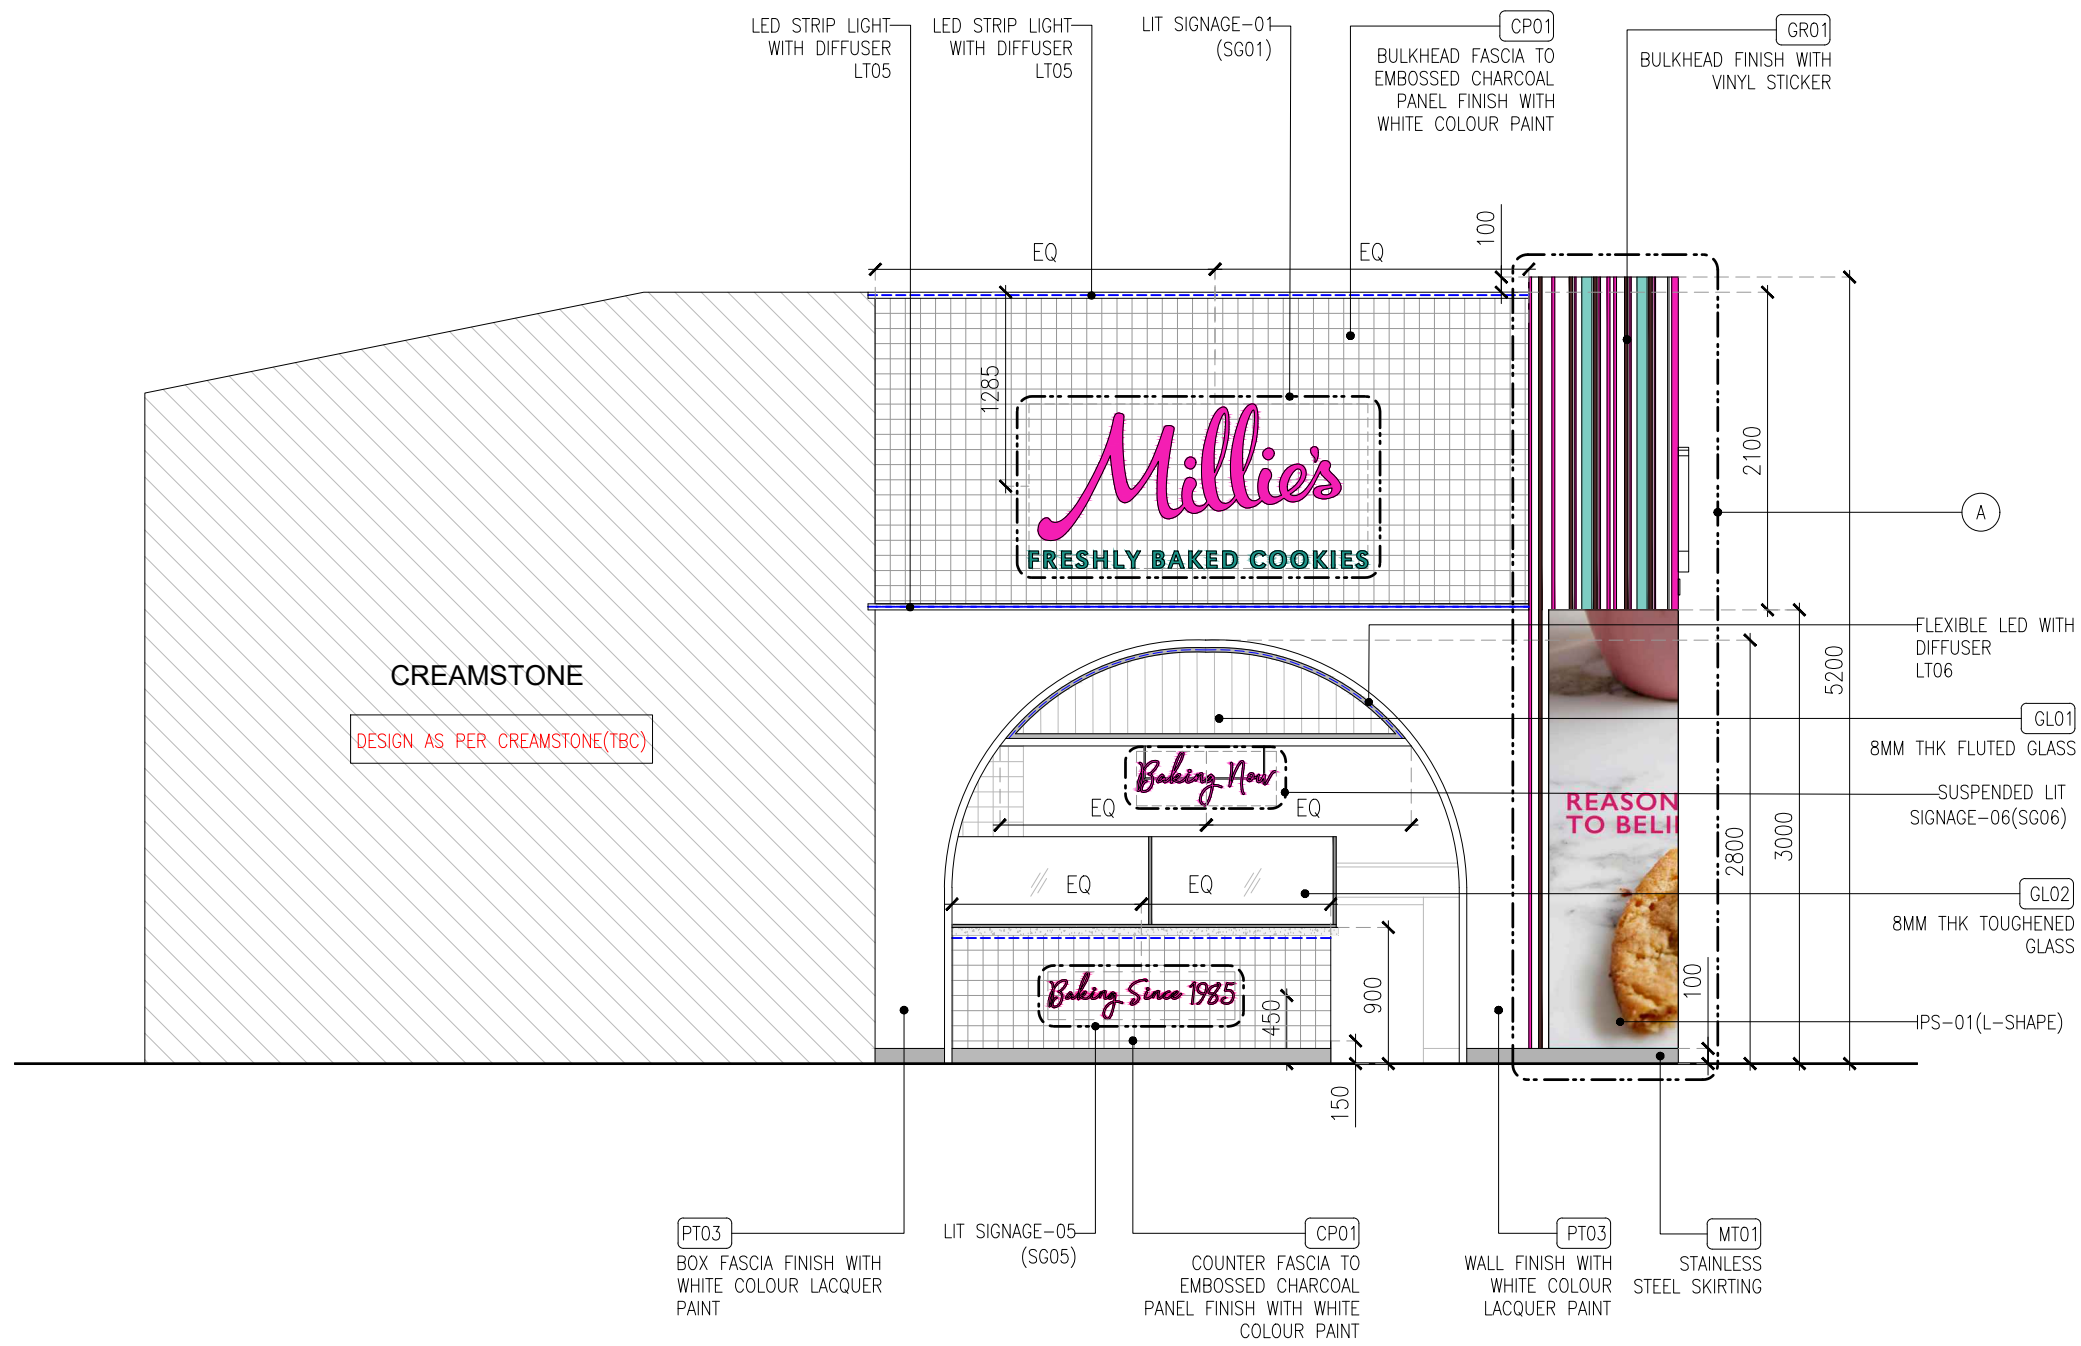

DETAIL-A(SCALE 1:40)

C01	01.03.24	GOOD FOR CONSTRUCTION	HOD	NM
REV	DATE	DESCRIPTION	DRN	CHK

01 ELEVATION-01
03IL-300 1:50




PROJECT
FF-025
MILLIE COOKIES
HYDERABAD AIRPORT

DRAWING TITLE
ELEVATION-01


SCALE AS MENTIONED DATE 01.03.2024 DRAWN HOD A3 SHEET

STATUS
GOOD FOR CONSTRUCTION


ORG	PROJECT NO	DRAWING TYPE	NUMBER	REV
TFS	XXXX 03IL	300	C01	

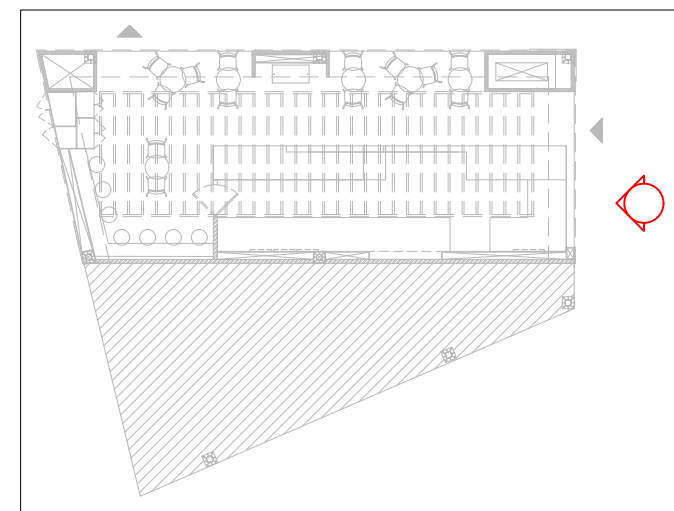

KEY PLAN

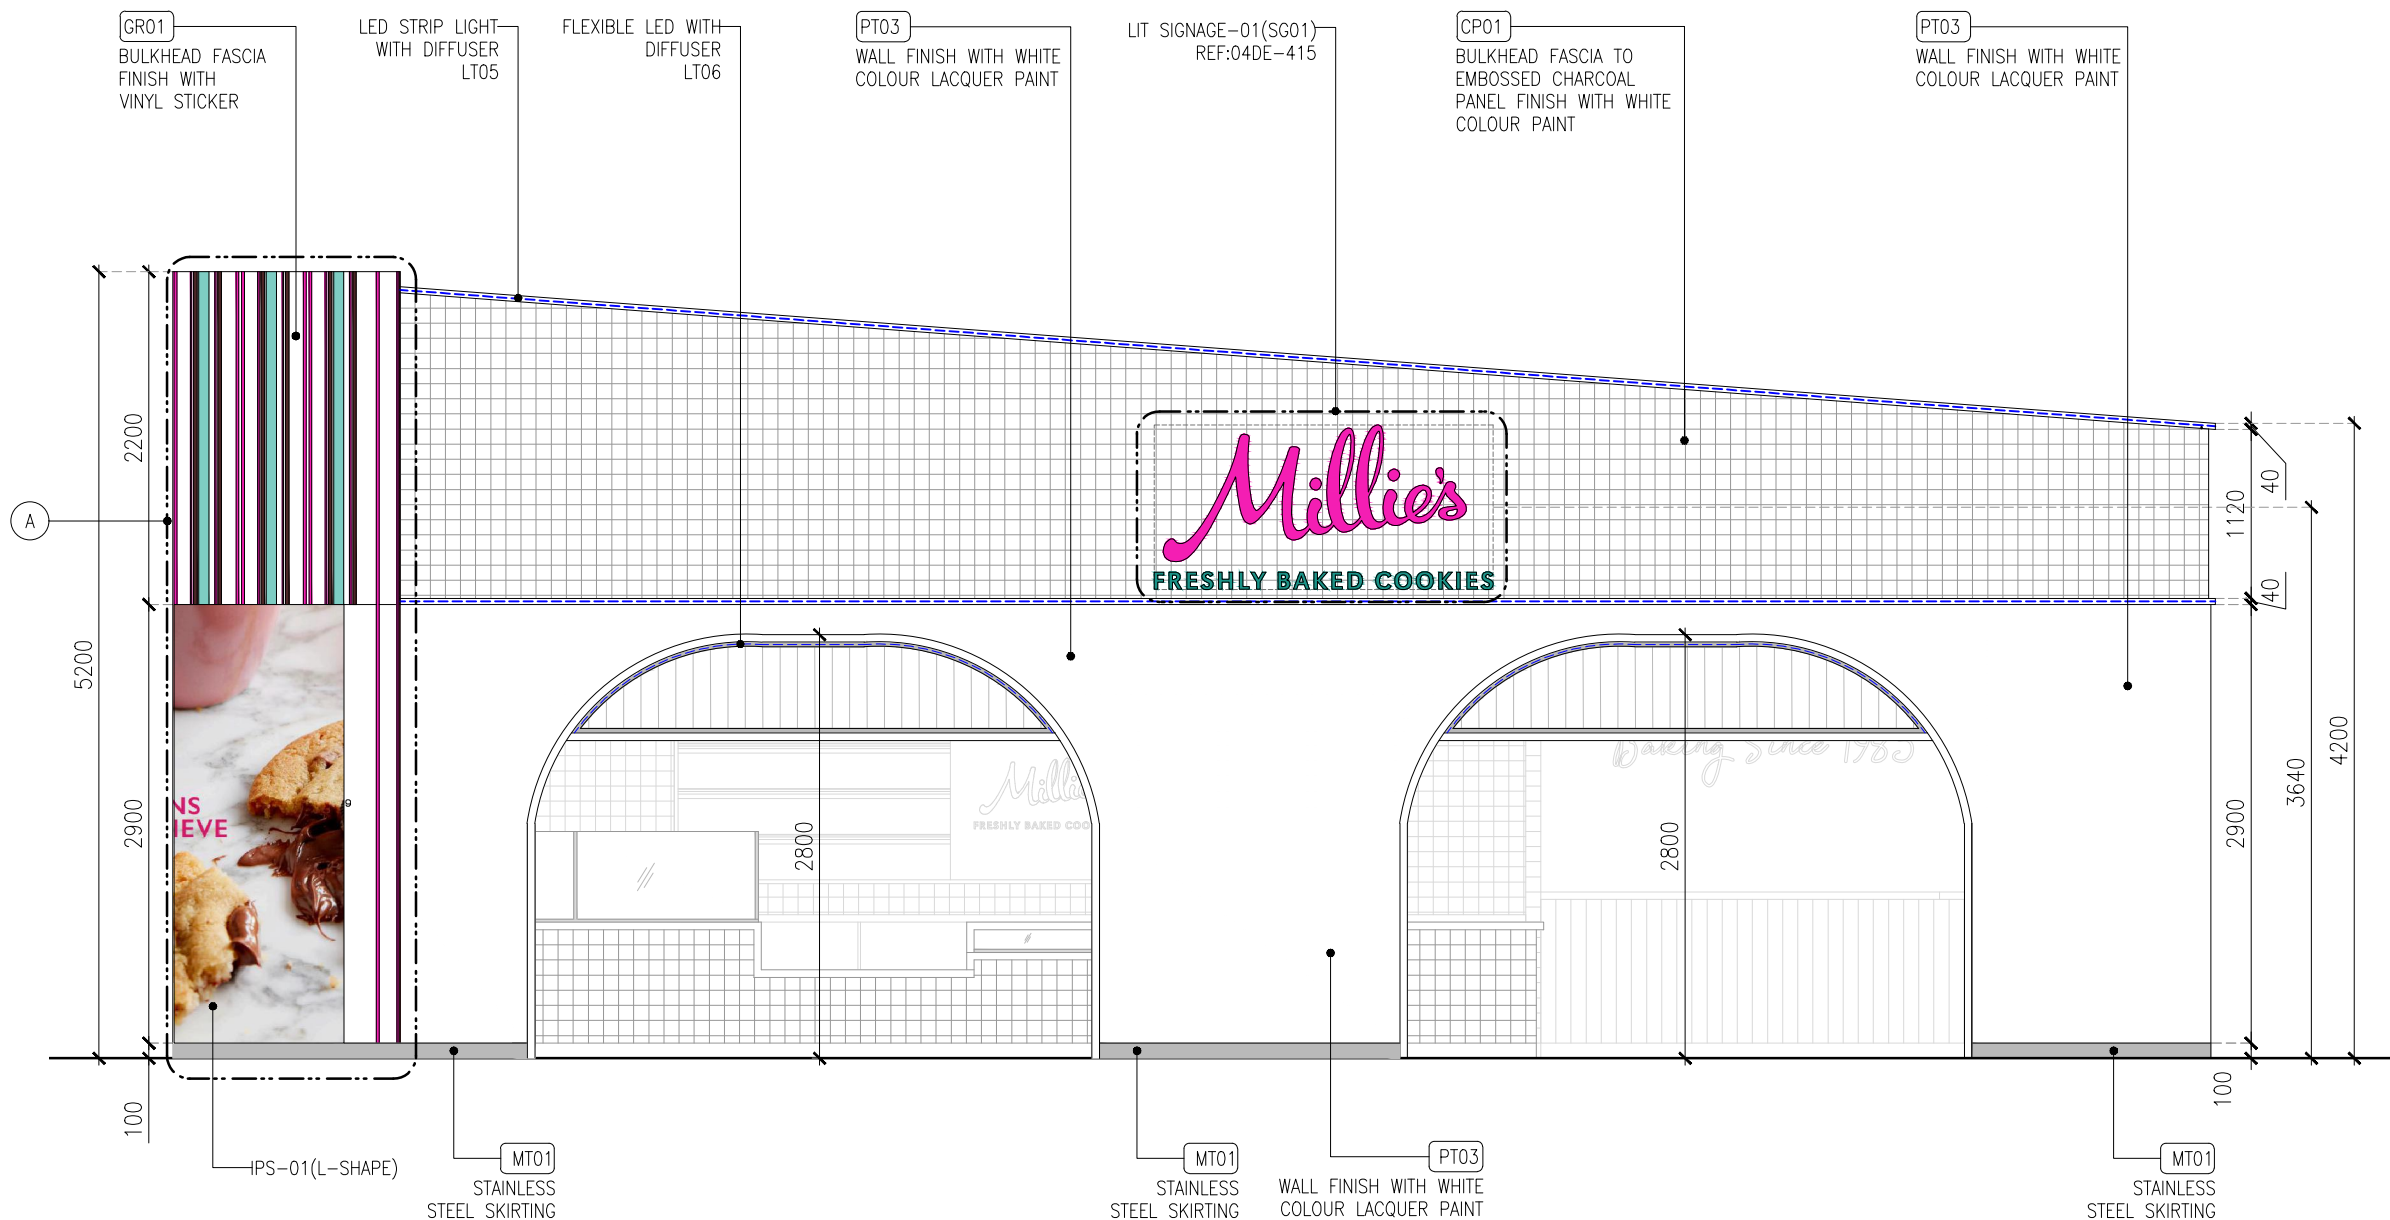

01 ELEVATION-02
03IL-301 1:50

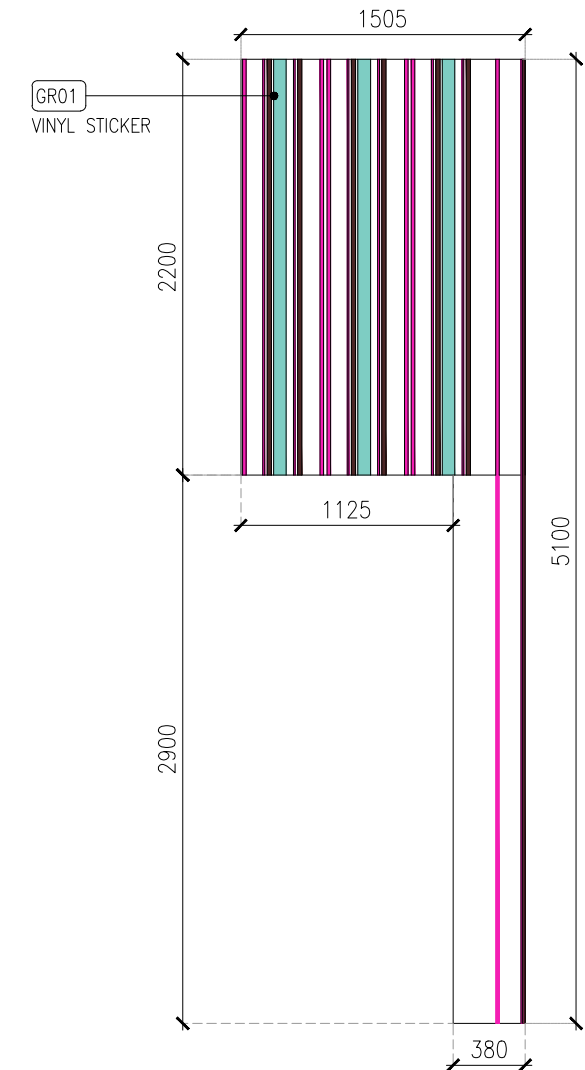

DETAIL-A(SCALE 1:40)

C01	01.03.24	GOOD FOR CONSTRUCTION	HOD NM
REV	DATE	DESCRIPTION	DRN CHK




PROJECT
FF-025
MILLIE COOKIES
HYDERABAD AIRPORT

DRAWING TITLE
ELEVATION-02


SCALE AS MENTIONED DATE 01.03.2024 DRAWN HOD A3 SHEET

STATUS
GOOD FOR CONSTRUCTION

ORG	PROJECT NO	DRAWING TYPE	NUMBER	REV
TFS	XXXX 03IL	301	C01	

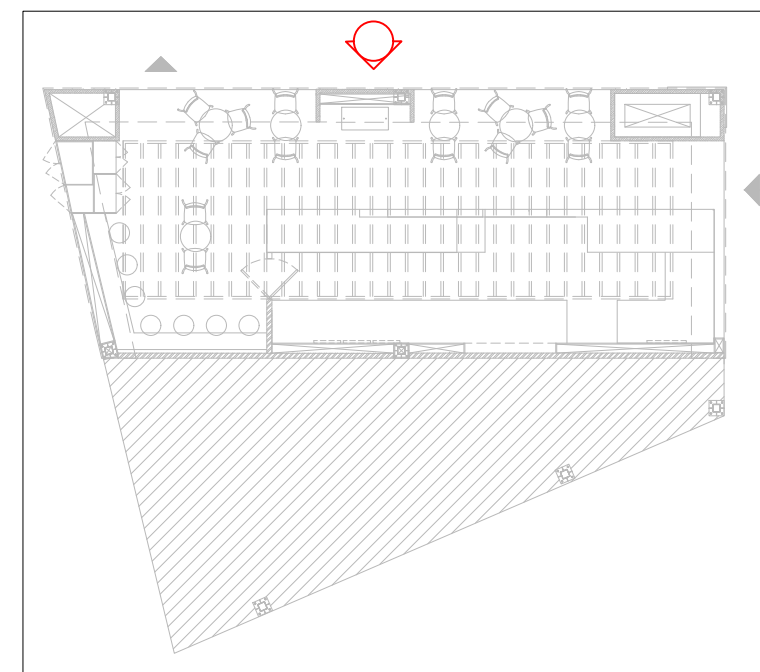


KEY PLAN

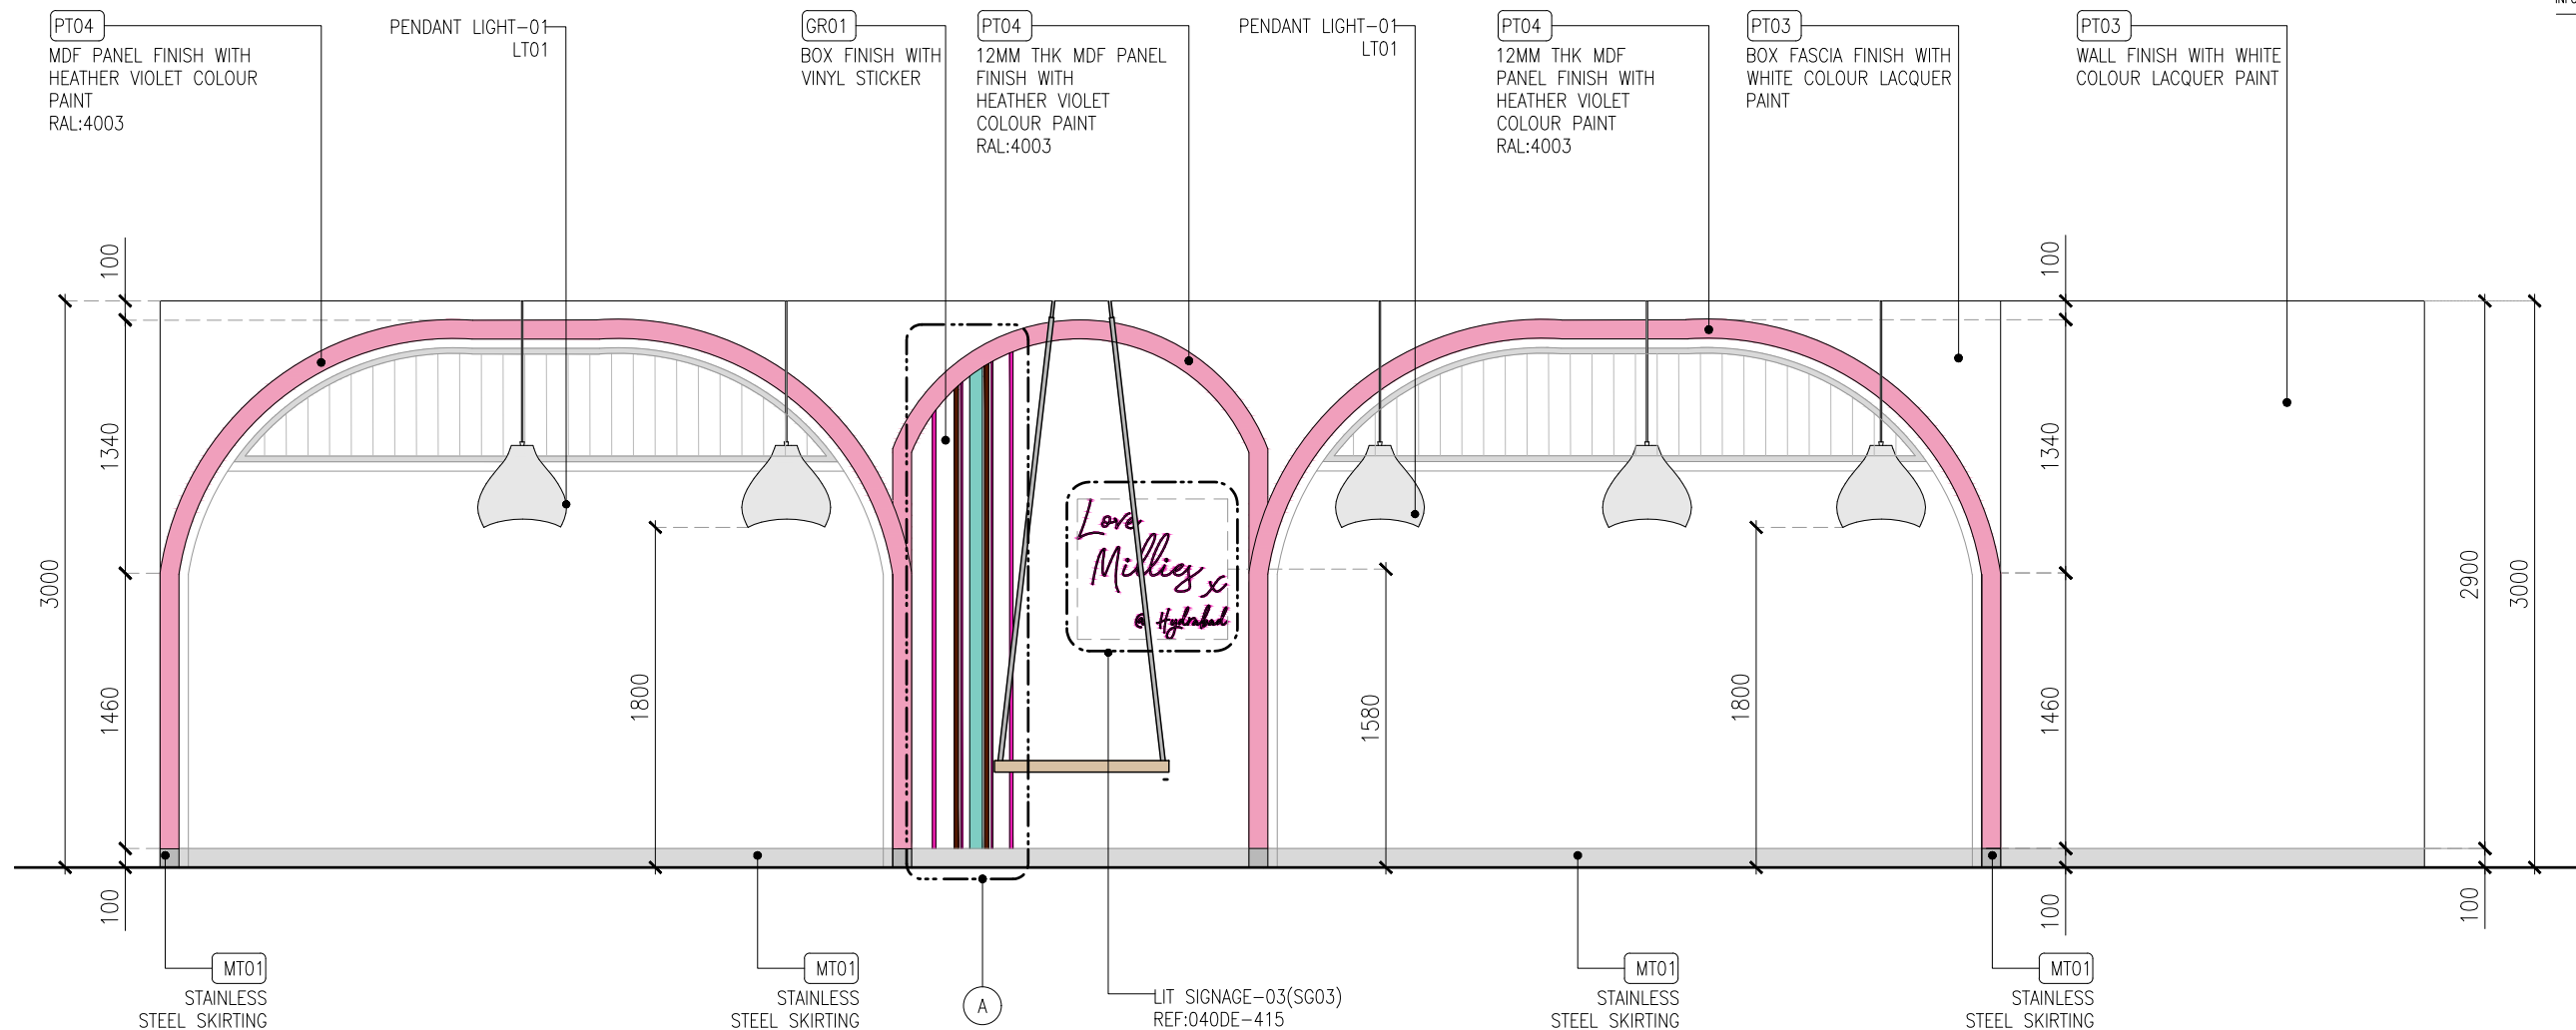


01 ELEVATION-03

03IL-302 1:40

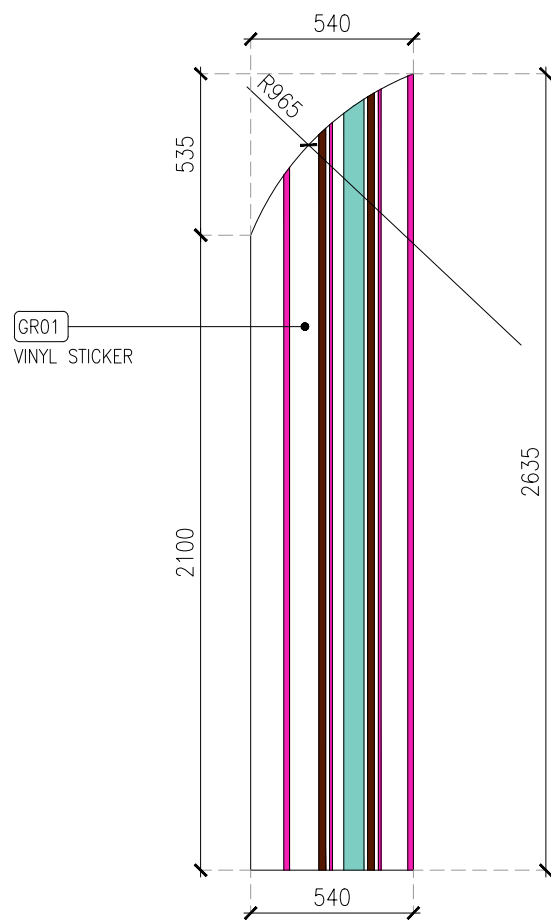

DETAIL-A(SCALE 1:25)

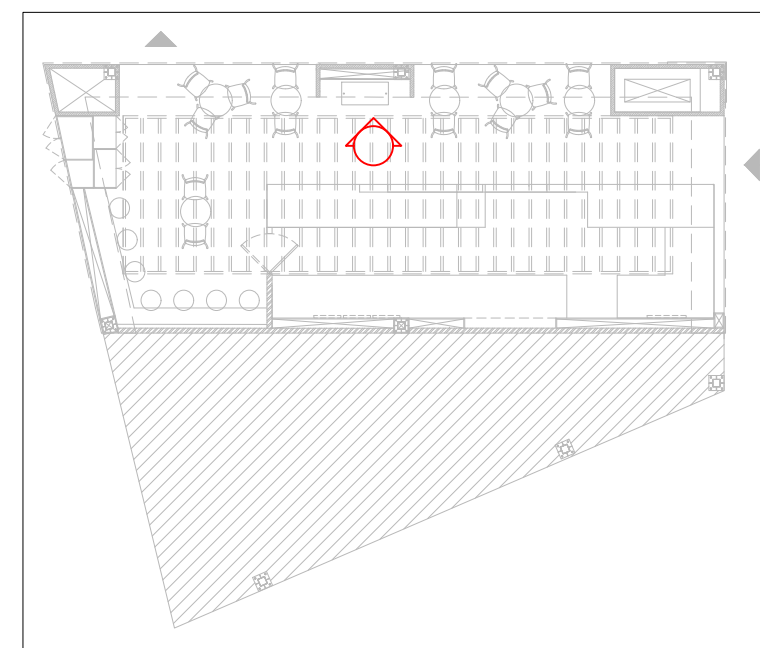

KEY PLAN

REV	DATE	DESCRIPTION	HOD	NM	DRN	CHK
C01	01.03.24	GOOD FOR CONSTRUCTION				




PROJECT
FF-025
MILIE COOKIES
HYDERABAD AIRPORT

DRAWING TITLE
ELEVATION-03


SCALE AS MENTIONED DATE 01.03.2024 DRAWN HOD A3 SHEET

STATUS
GOOD FOR CONSTRUCTION

ORG	PROJECT NO	DRAWING TYPE	NUMBER	REV
TFS	XXXX	03IL	302	C01

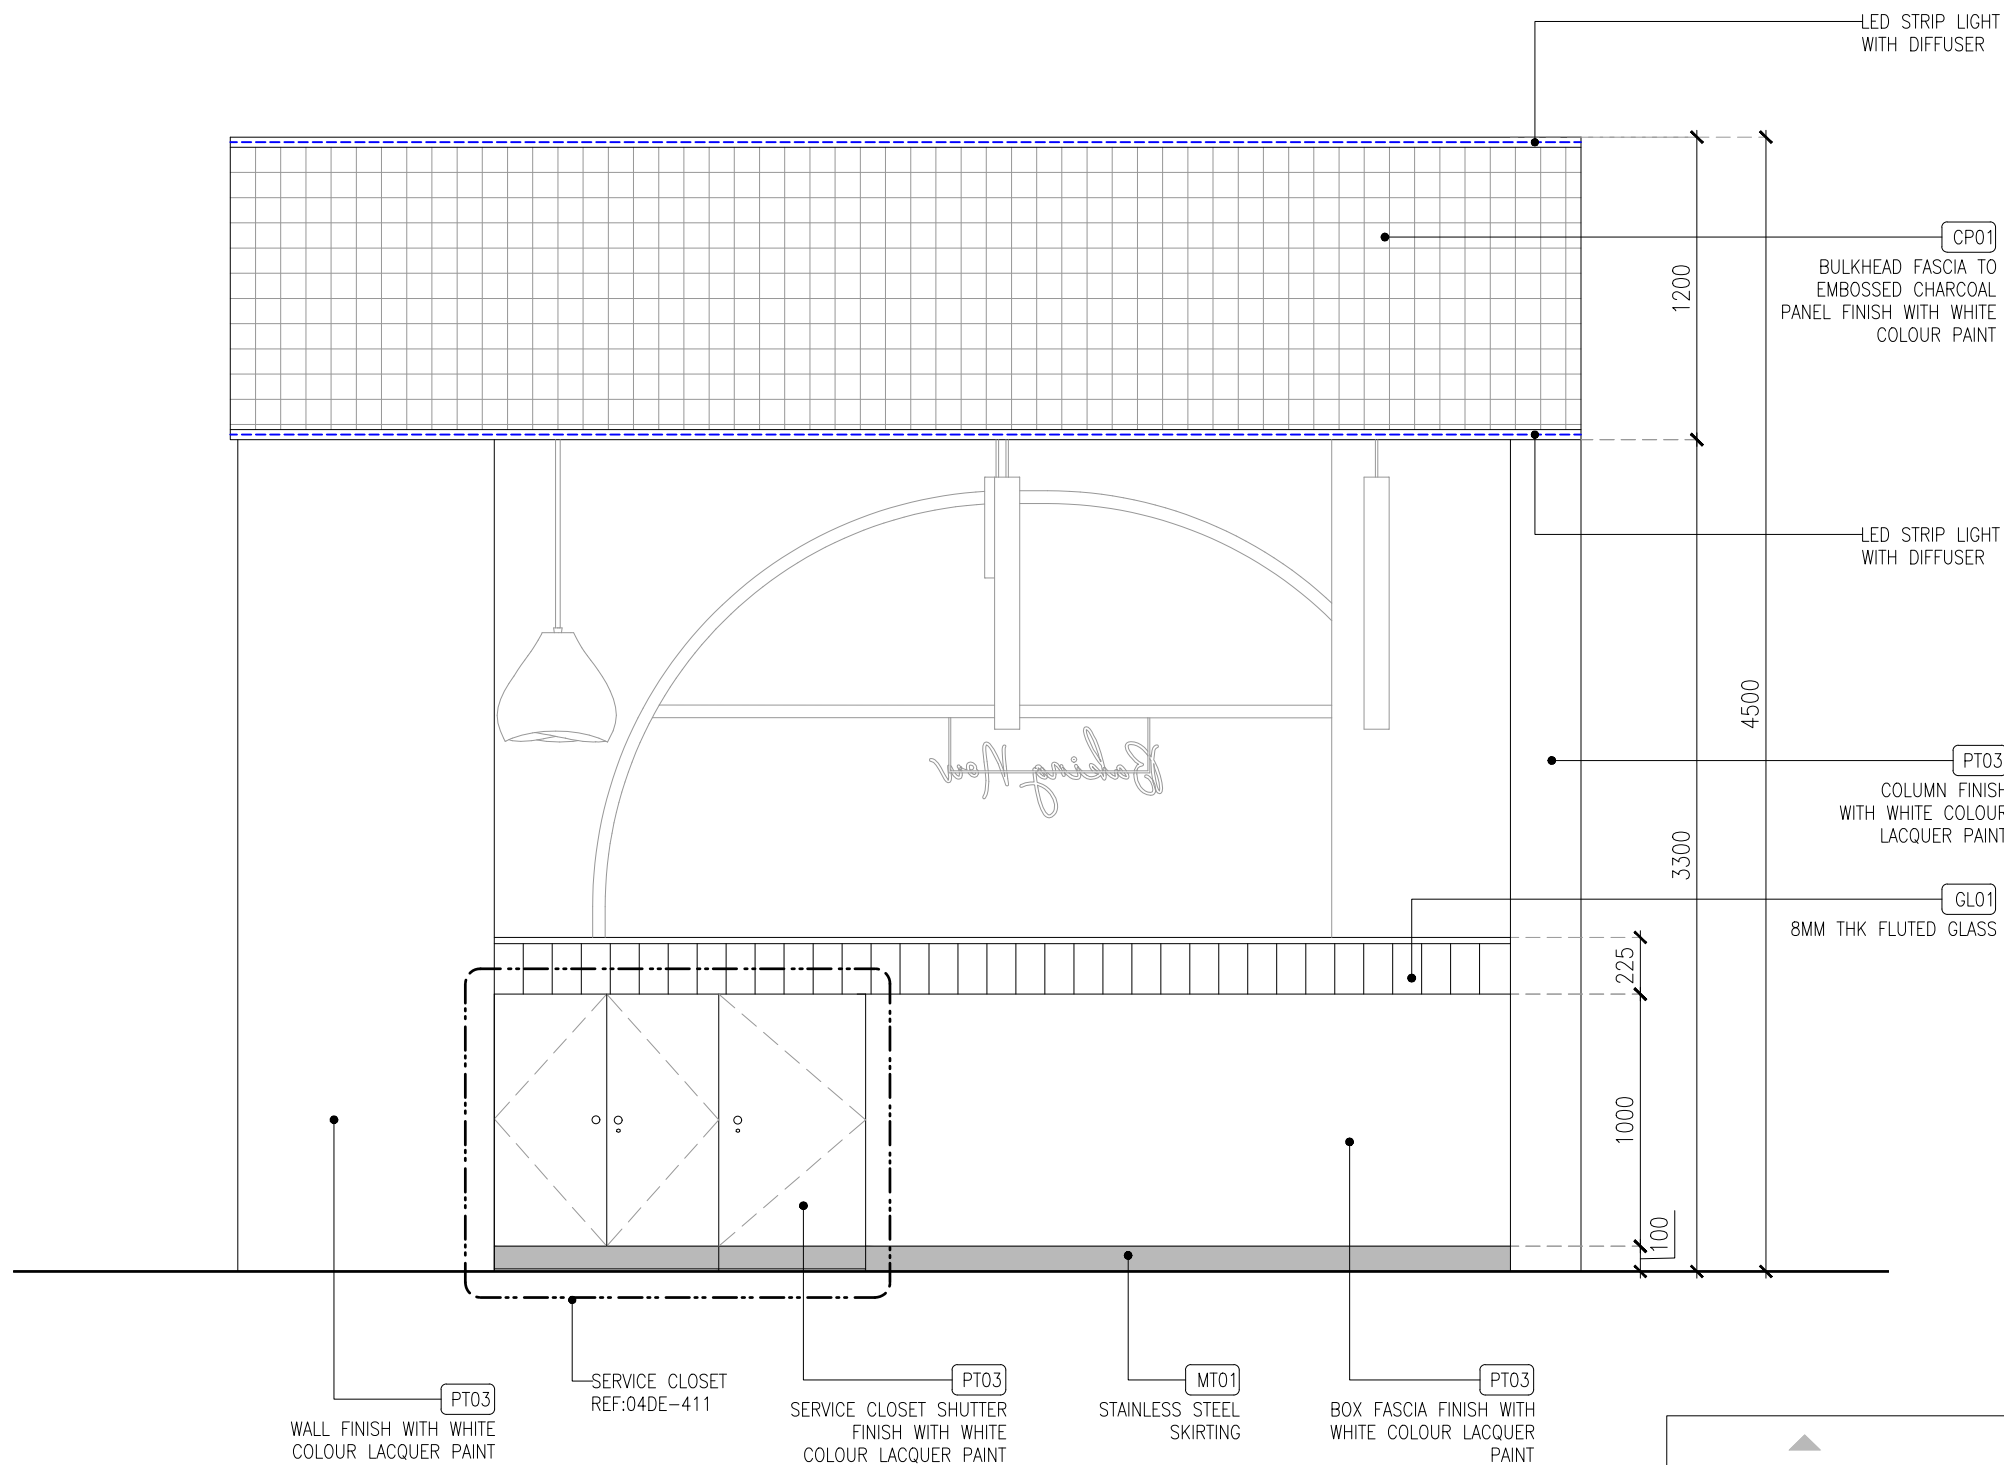

01 ELEVATION-04
03IL-303 1:30

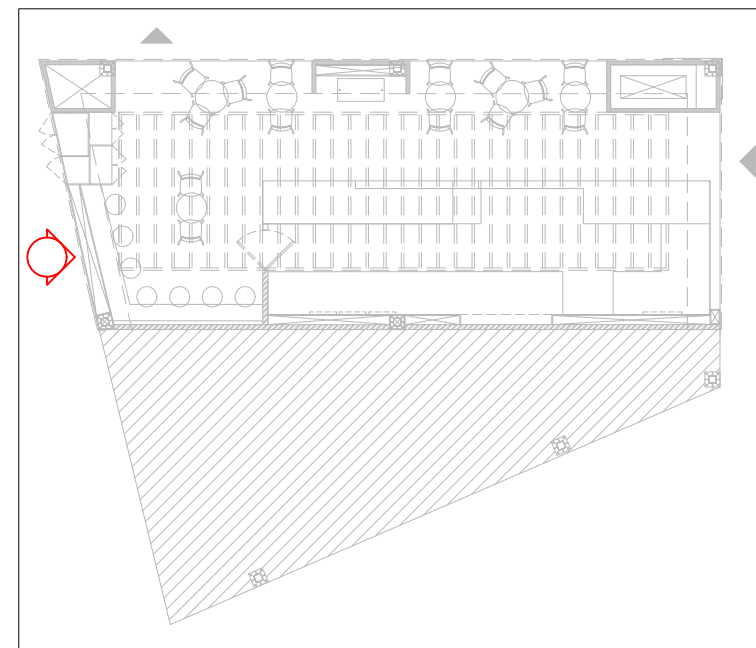

KEY PLAN

C01	01.03.24	GOOD FOR CONSTRUCTION	HOD	NM
REV	DATE	DESCRIPTION	DRN	CHK




PROJECT
FF-025
MILIE COOKIES
HYDERABAD AIRPORT

DRAWING TITLE
ELEVATION-04


SCALE 1:30 DATE 01.03.2024 DRAWN HOD A3 SHEET

STATUS
GOOD FOR CONSTRUCTION


ORG	PROJECT NO	DRAWING TYPE	NUMBER	REV
TFS	XXXX 03IL	303	C01	

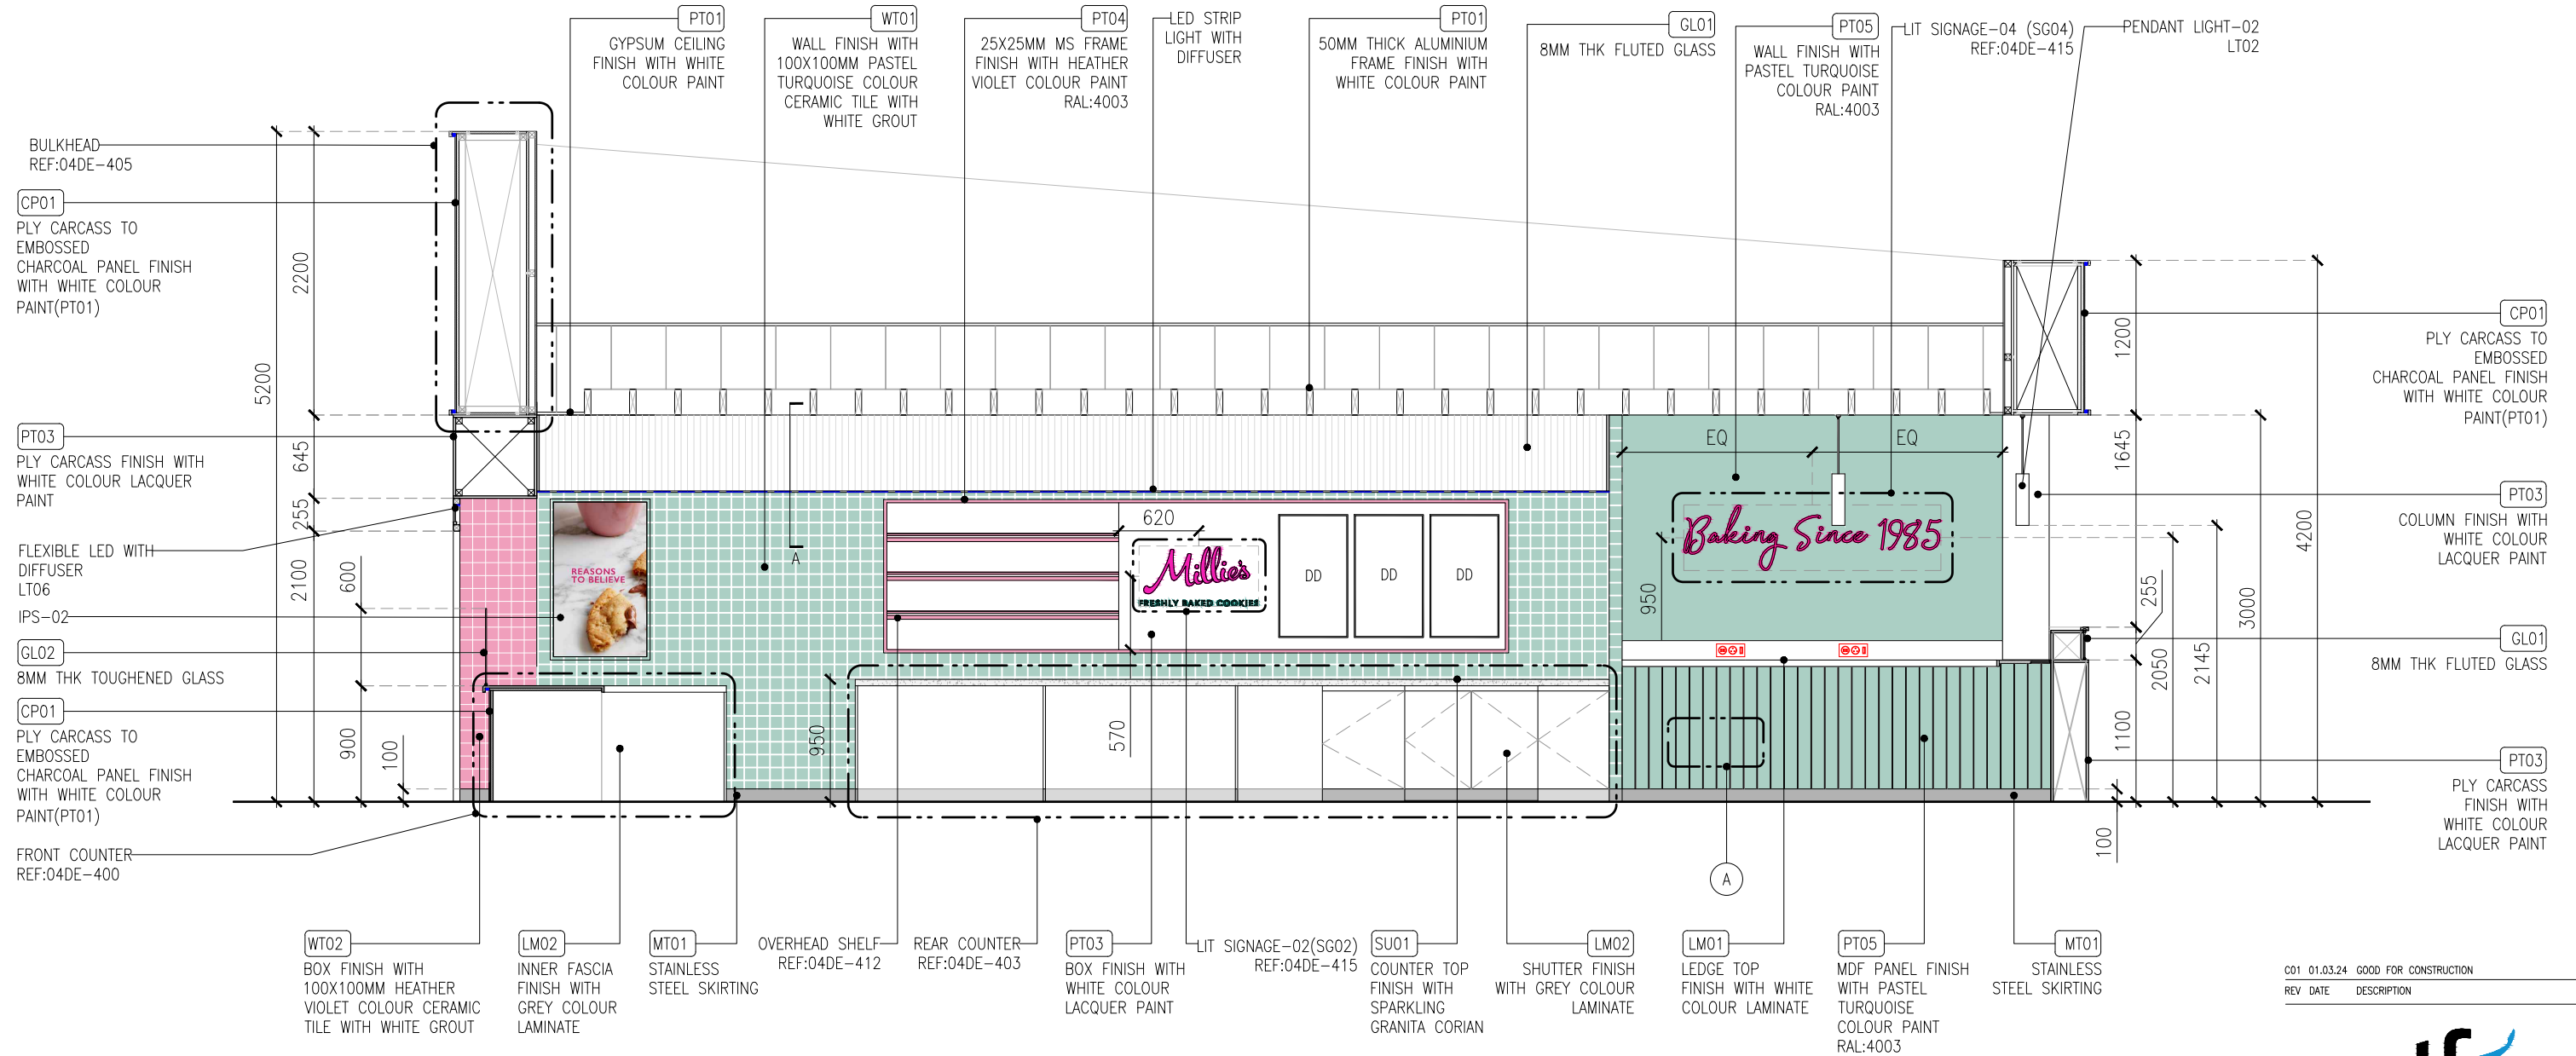


01 SECTION-01
03L-304 1:50

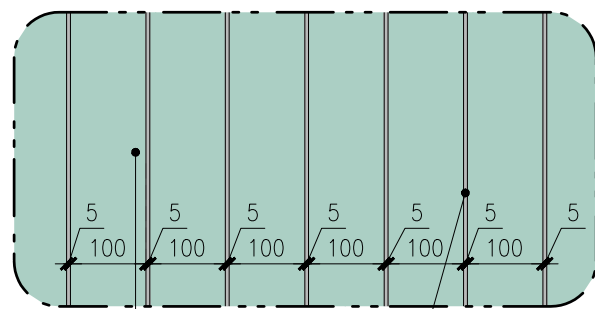

DETAIL-A(SCALE 1:10)

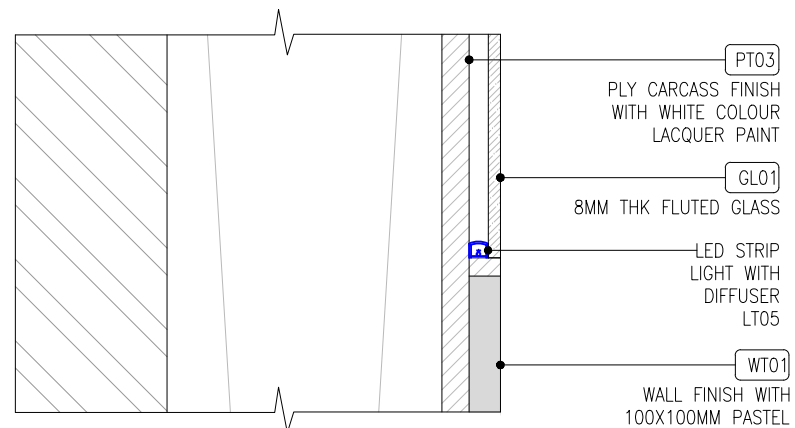

SECTION -A(SCALE 1:5)

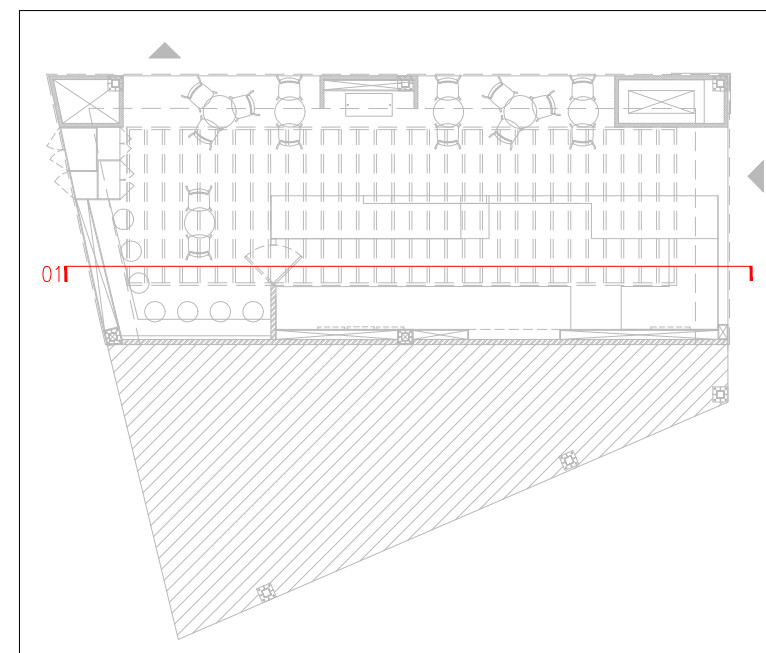

KEY PLAN

REV	DATE	DESCRIPTION	DRN	CHK
C01	01.03.24	GOOD FOR CONSTRUCTION		




PROJECT
FF-025
MILLIE COOKIES
HYDERABAD AIRPORT

DRAWING TITLE
SECTION-01


SCALE AS MENTIONED DATE 01.03.2024 DRAWN HOD A3 SHEET

STATUS
GOOD FOR CONSTRUCTION

ORG PROJECT NO DRAWING TYPE NUMBER REV
TFS XXXX 03IL 304 C01

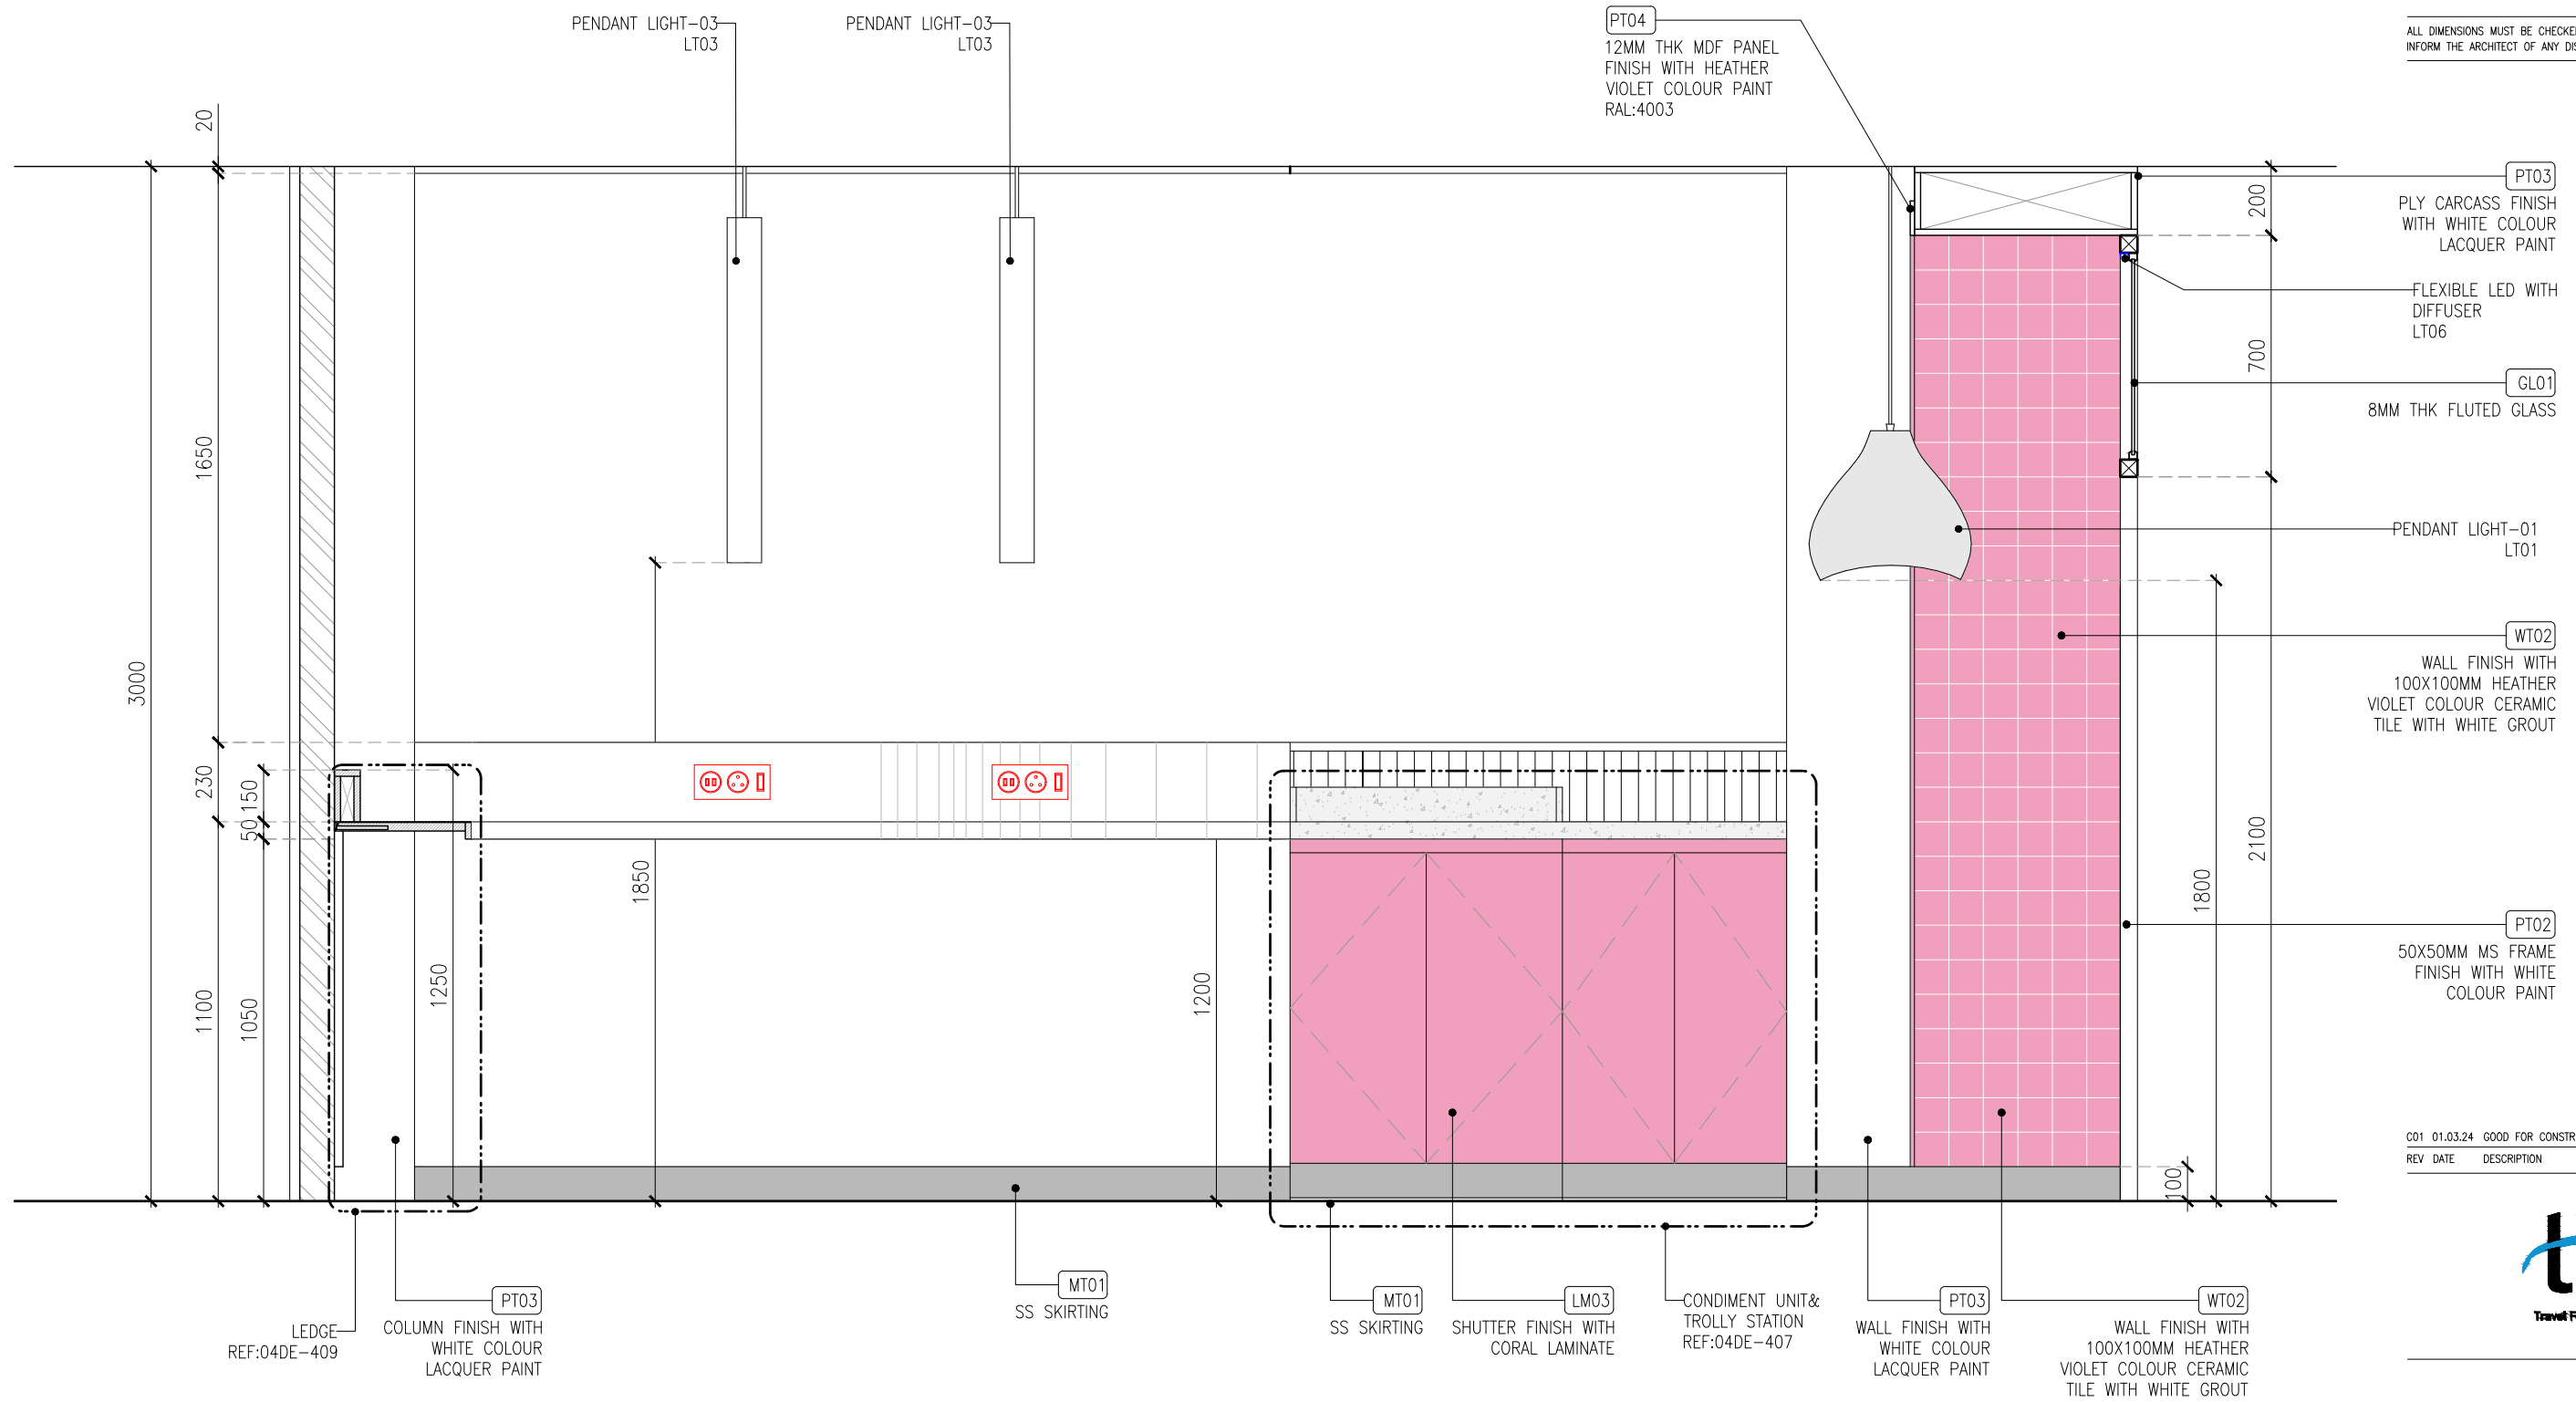

01 SECTION-02
03IL-305 1:20

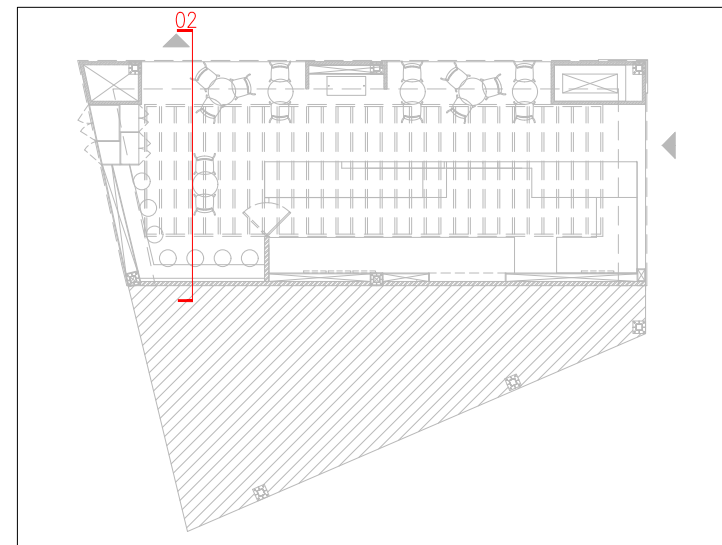

KEY PLAN

C01	01.03.24	GOOD FOR CONSTRUCTION	HOD NM
REV	DATE	DESCRIPTION	DRN CHK






PROJECT
FF-025
MILIE COOKIES
HYDERABAD AIRPORT

DRAWING TITLE
SECTION-02

SCALE 1:20 DATE 01.03.2024 DRAWN HOD A3 SHEET

STATUS
GOOD FOR CONSTRUCTION

ORG	PROJECT NO	DRAWING TYPE	NUMBER	REV
TFS	XXXX	03IL	305	C01

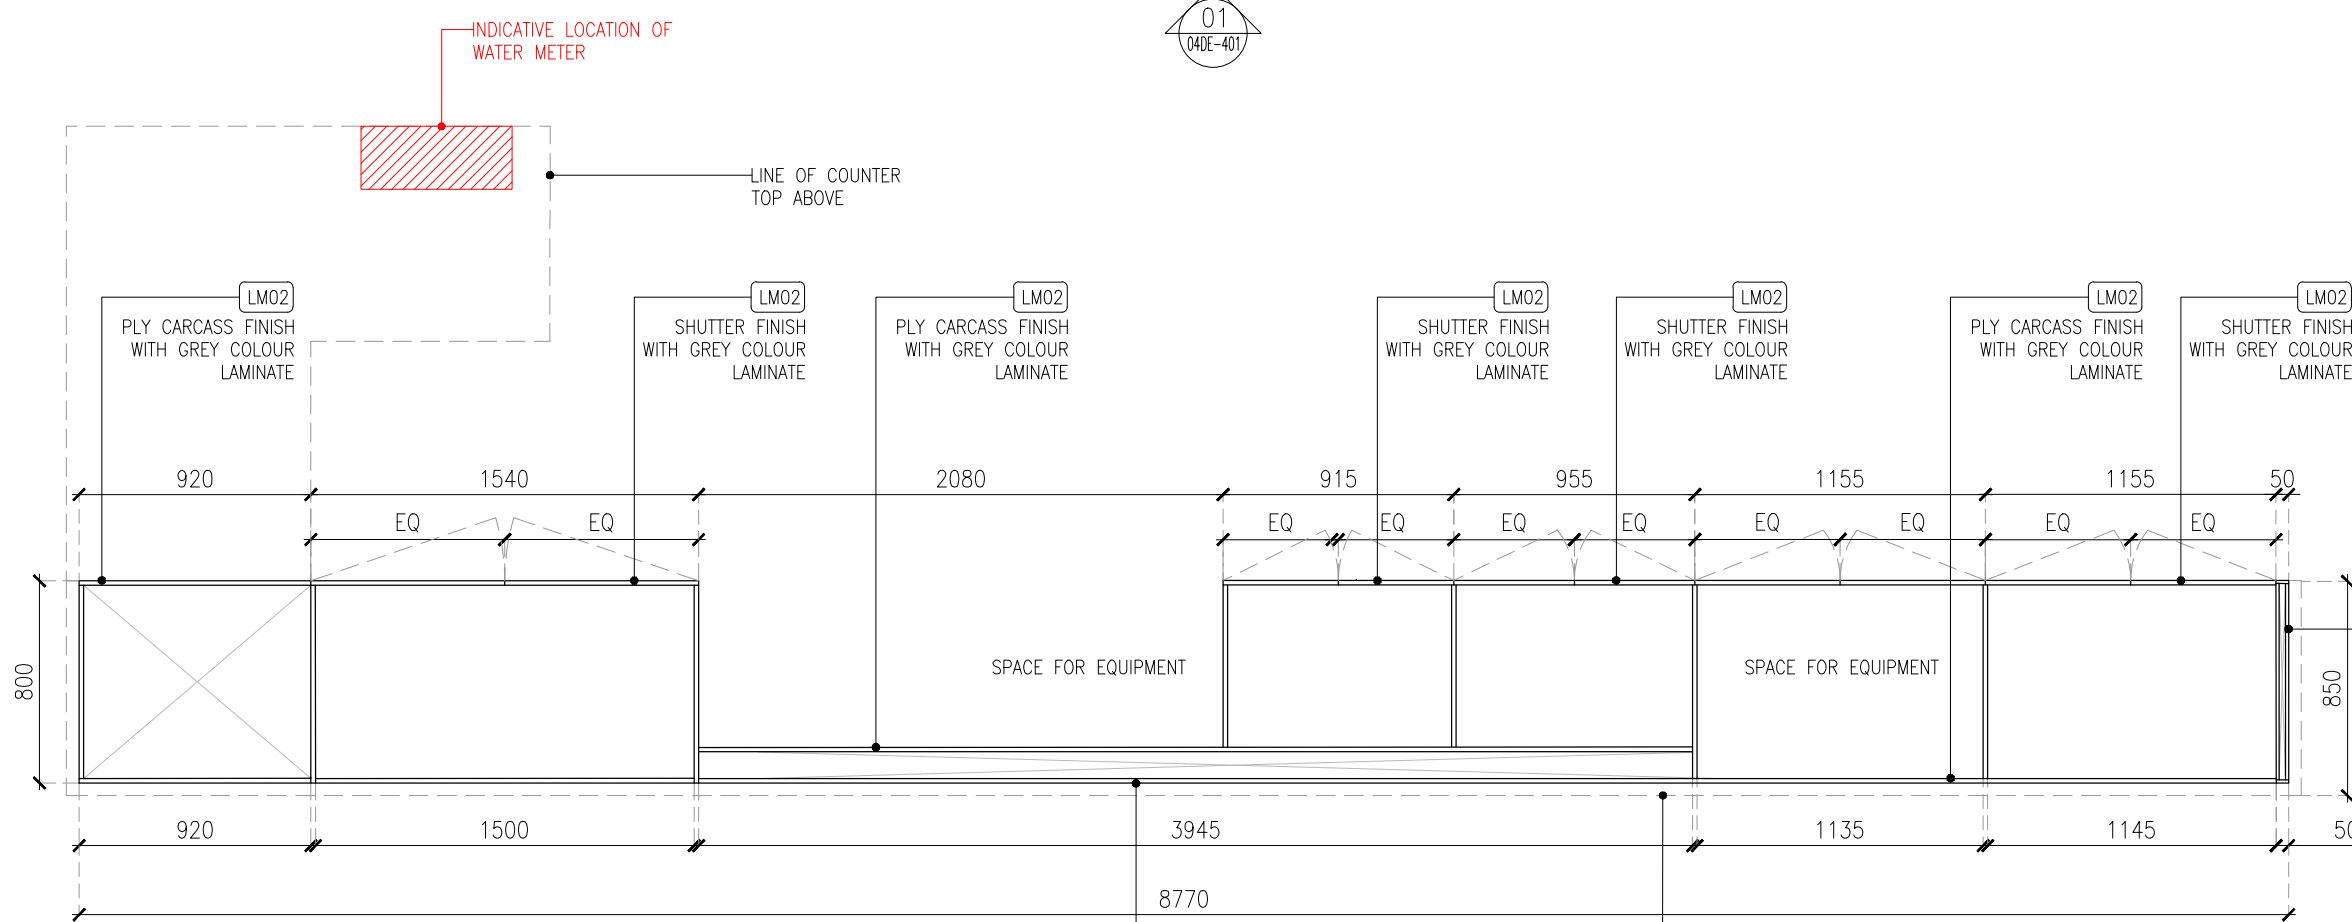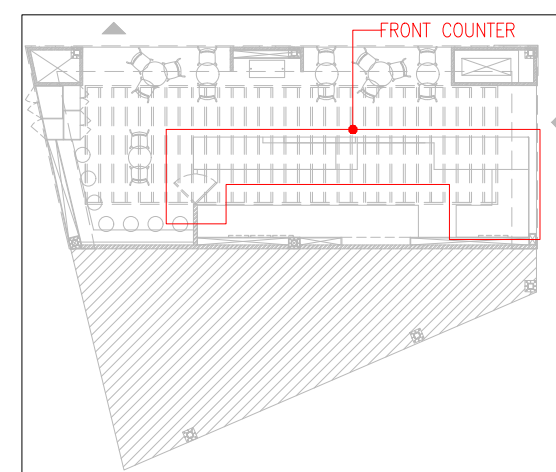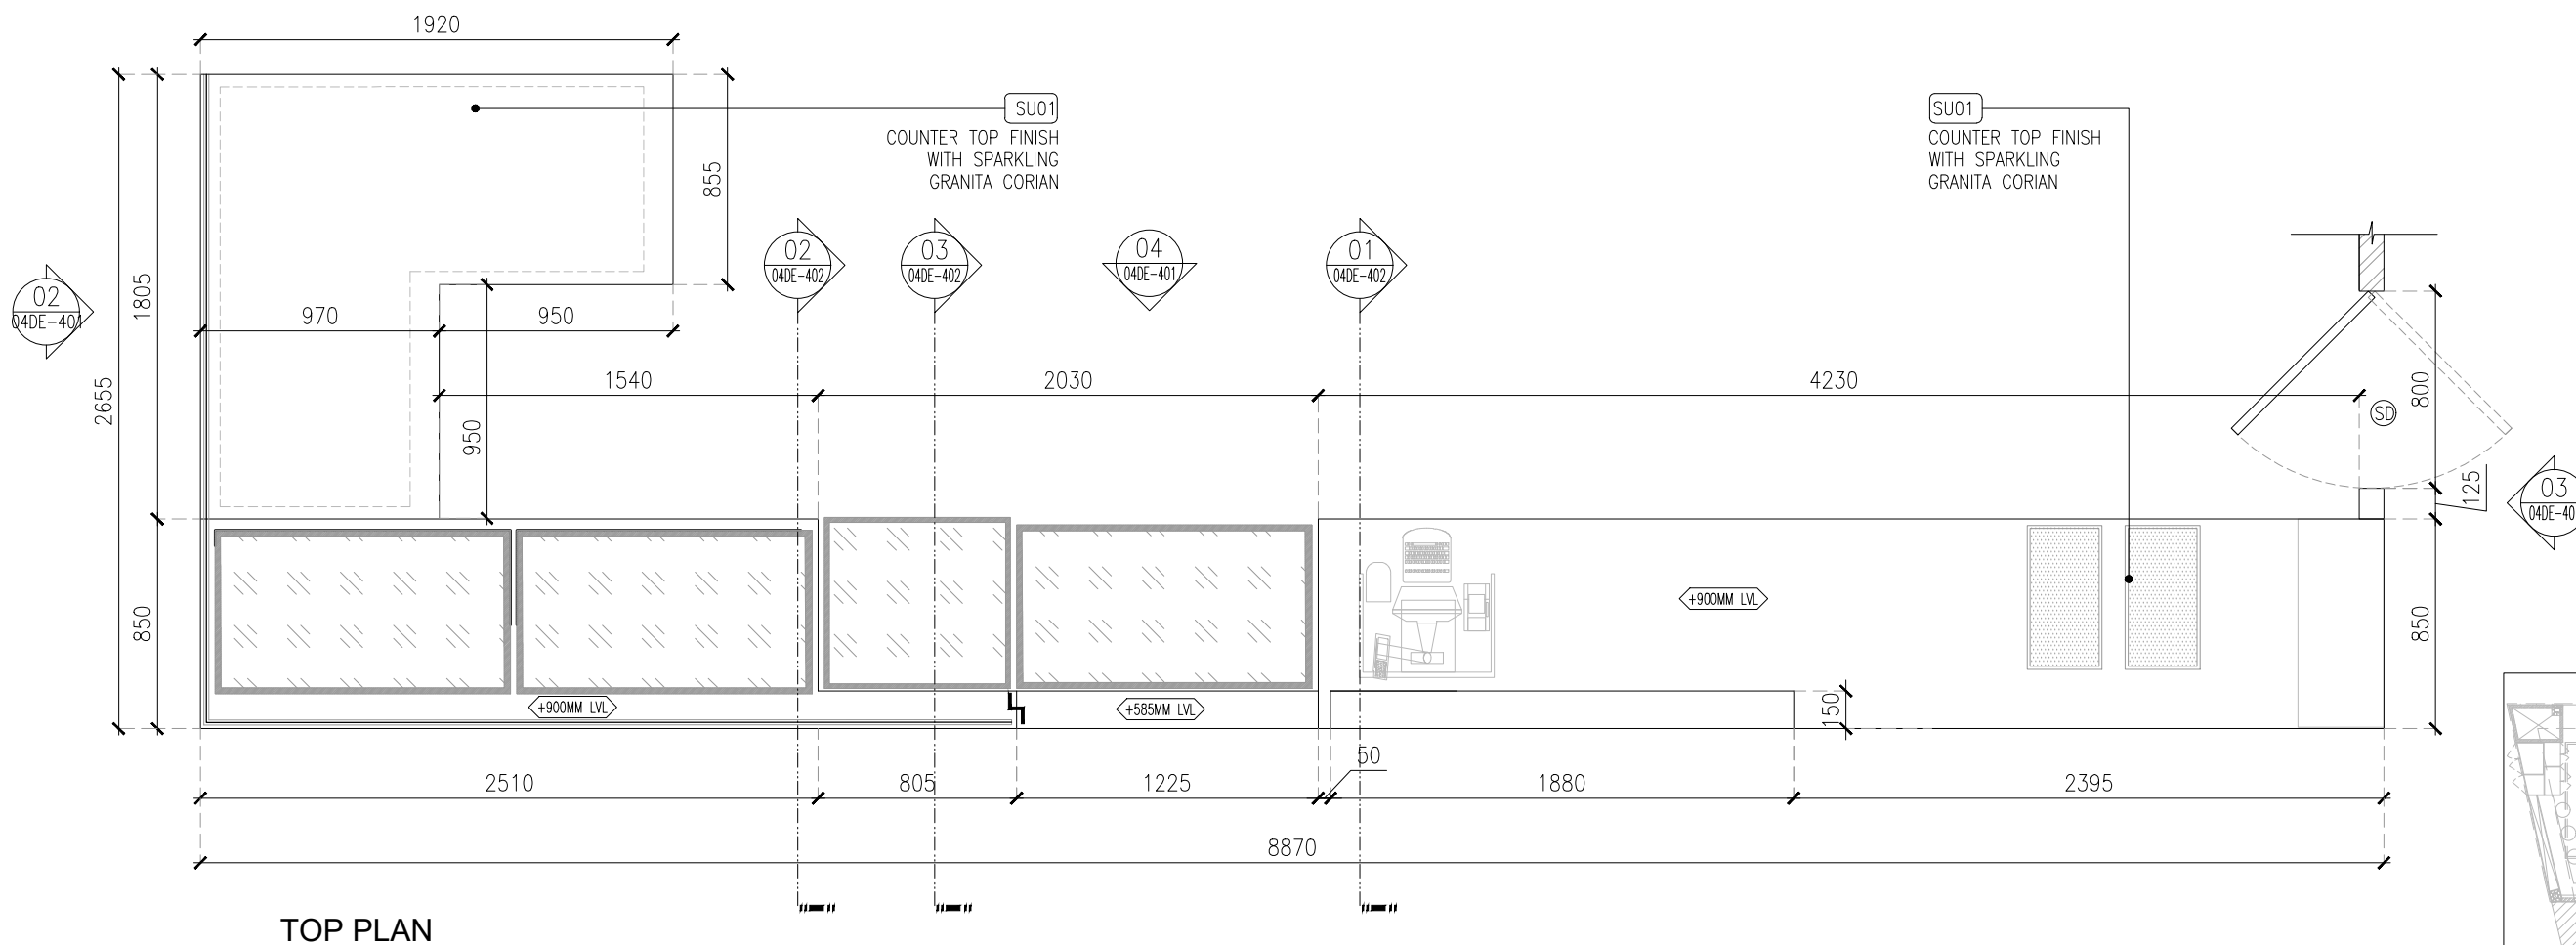

KEY PLAN

C01	01.03.24	GOOD FOR CONSTRUCTION	HOD	NM
REV	DATE	DESCRIPTION	DRN	CHK



PROJECT
FF-025
MILIE COOKIES
HYDERABAD AIRPORT

DRAWING TITLE
J01-FRONT COUNTER DETAIL PART-A

SCALE	DATE	DRAWN	HOD	A3	SHEET
1:30	01.03.2024				

STATUS
GOOD FOR CONSTRUCTION

ORG	PROJECT NO	DRAWING TYPE	NUMBER	REV
TFS	XXXX	04DE	400	C01


J01-FRONT COUNTER DETAIL PART-A

01
04DE-401
1:30


CP01
PLY CARCASS TO EMBOSSED CHARCOAL PANEL FINISH WITH WHITE COLOUR PAINT (PT01)

LINE OF COUNTER TOP ABOVE


ALL DIMENSIONS MUST BE CHECKED ON SITE
INFORM THE ARCHITECT OF ANY DISCREPANCIES PRIOR TO CONSTRUCTION

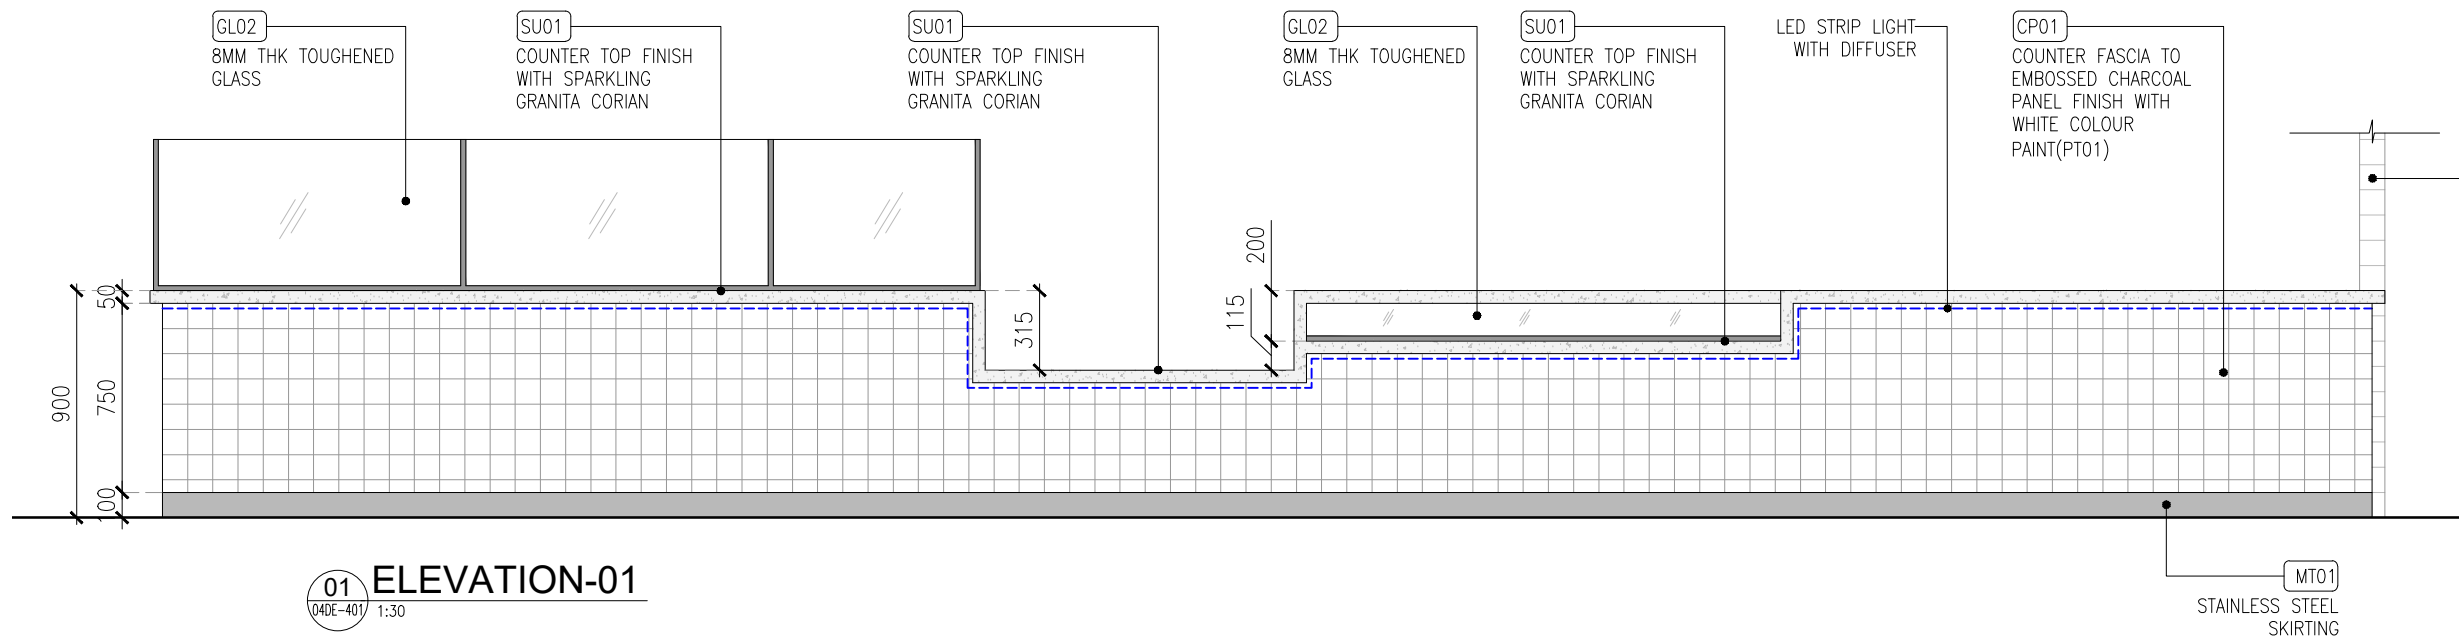


01 ELEVATION-01
04DE-401 1:30

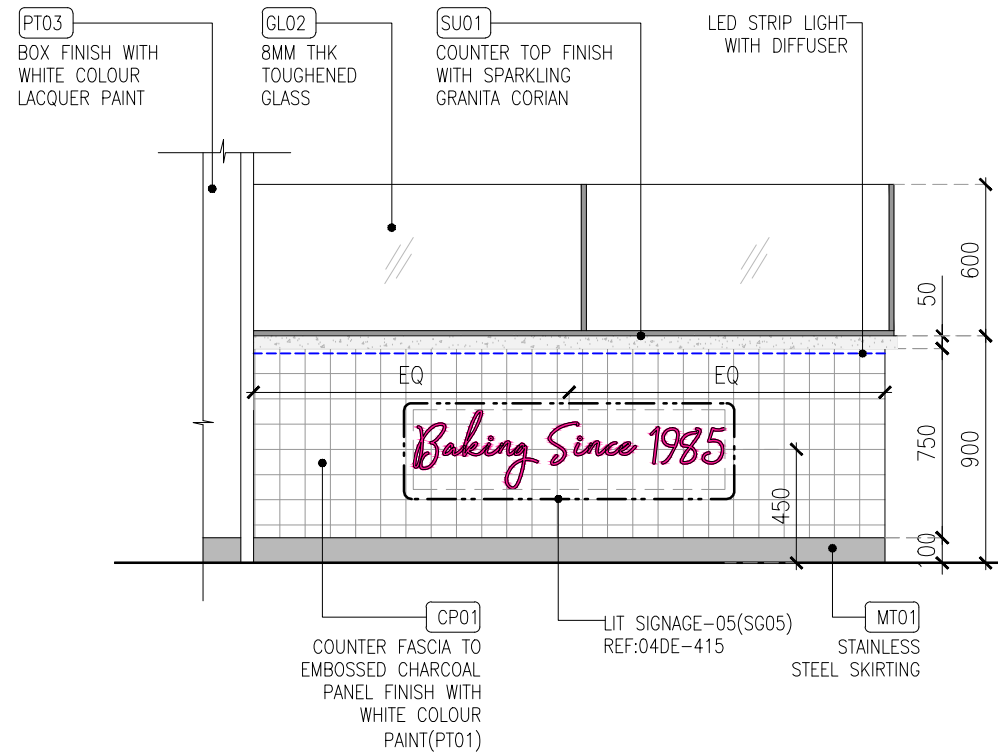

02 ELEVATION-02
04DE-401 1:30

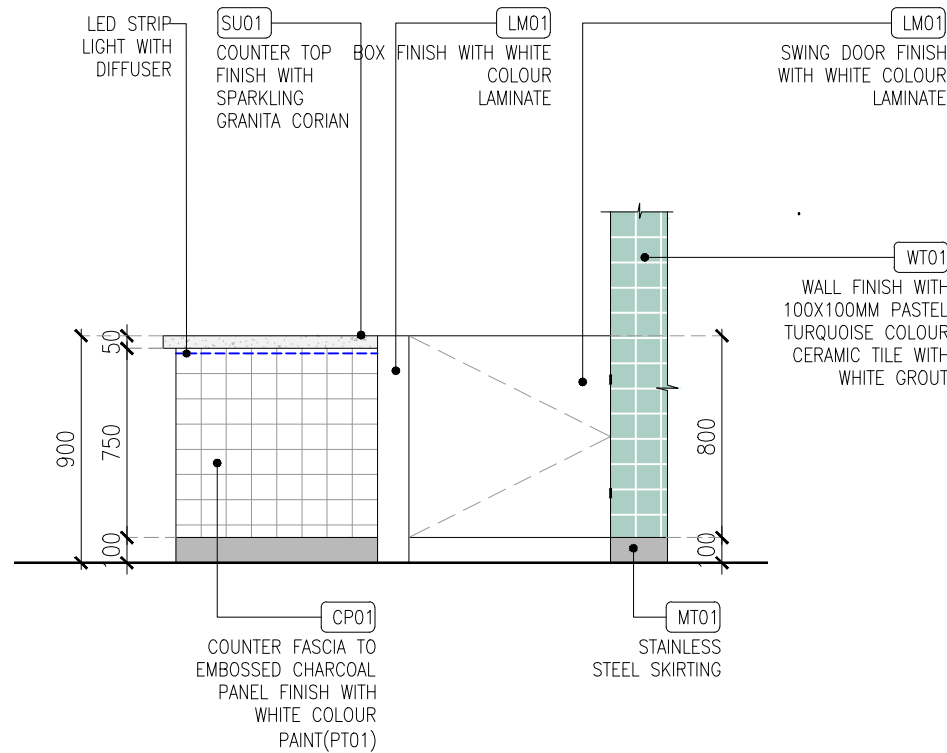

03 ELEVATION-03
04DE-401 1:30

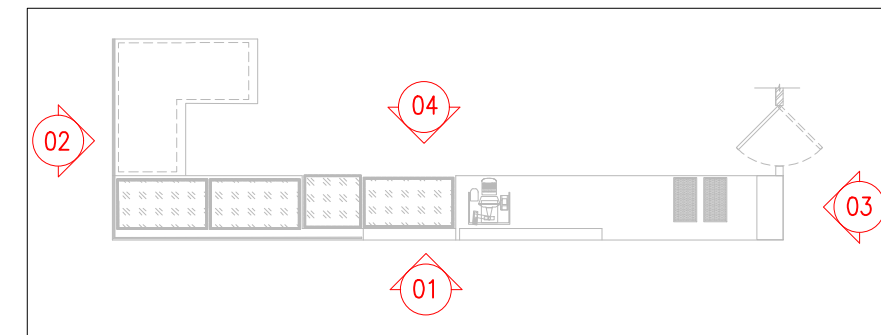

KEY PLAN

C01	01.03.24	GOOD FOR CONSTRUCTION	HOD	NM
REV	DATE	DESCRIPTION	DRN	CHK




PROJECT
FF-025
MILIE COOKIES
HYDERABAD AIRPORT

DRAWING TITLE
J01-FRONT COUNTER DETAIL PART-B

SCALE 1:30 DATE 01.03.2024 DRAWN HOD A3 SHEET


STATUS
GOOD FOR CONSTRUCTION

ORG	PROJECT NO	DRAWING TYPE	NUMBER	REV
TFS	XXXX	04DE	401	C01

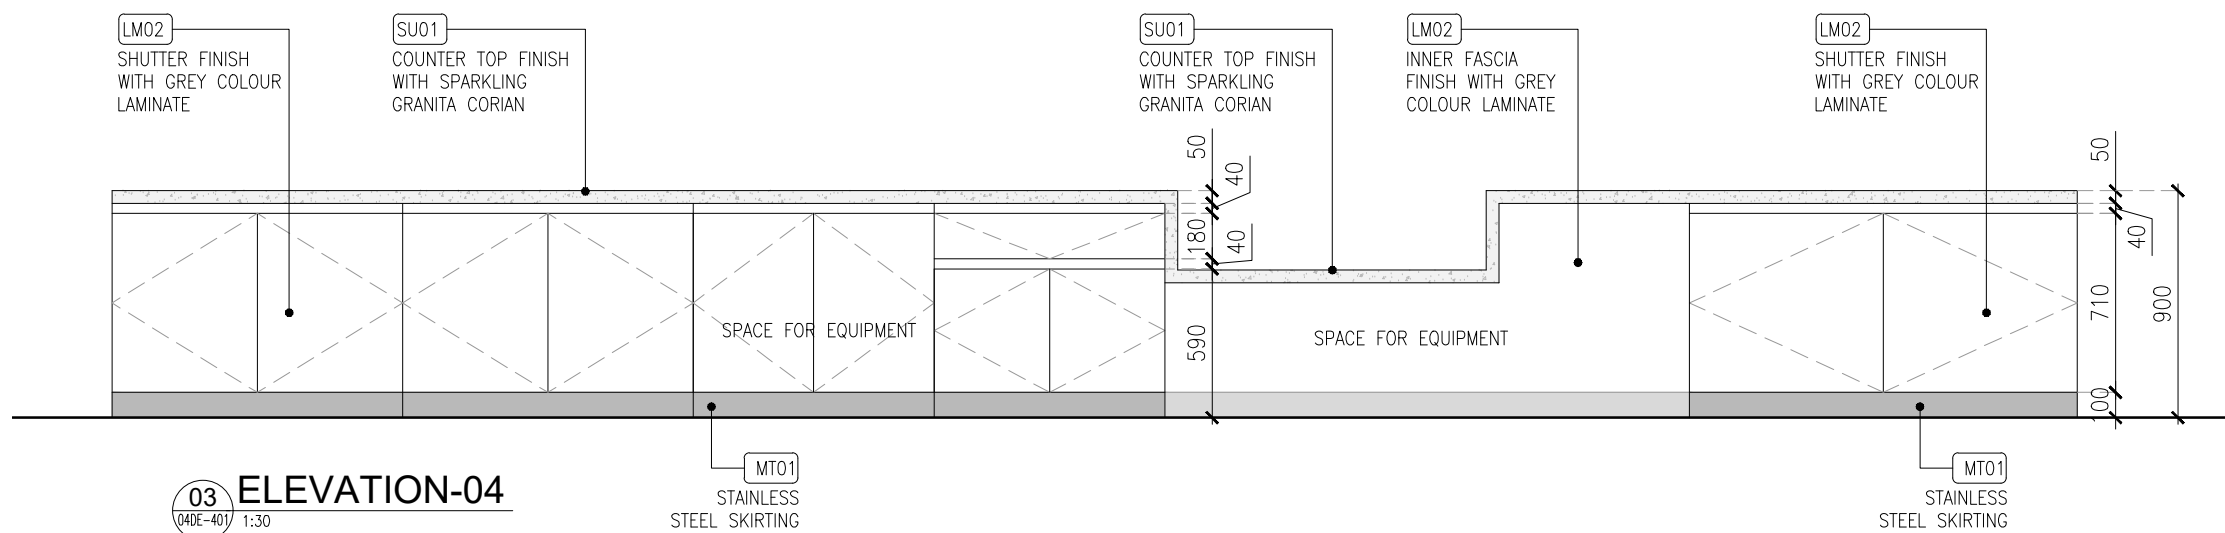


03 ELEVATION-04
04DE-401 1:30


ALL DIMENSIONS MUST BE CHECKED ON SITE
INFORM THE ARCHITECT OF ANY DISCREPANCIES PRIOR TO CONSTRUCTION

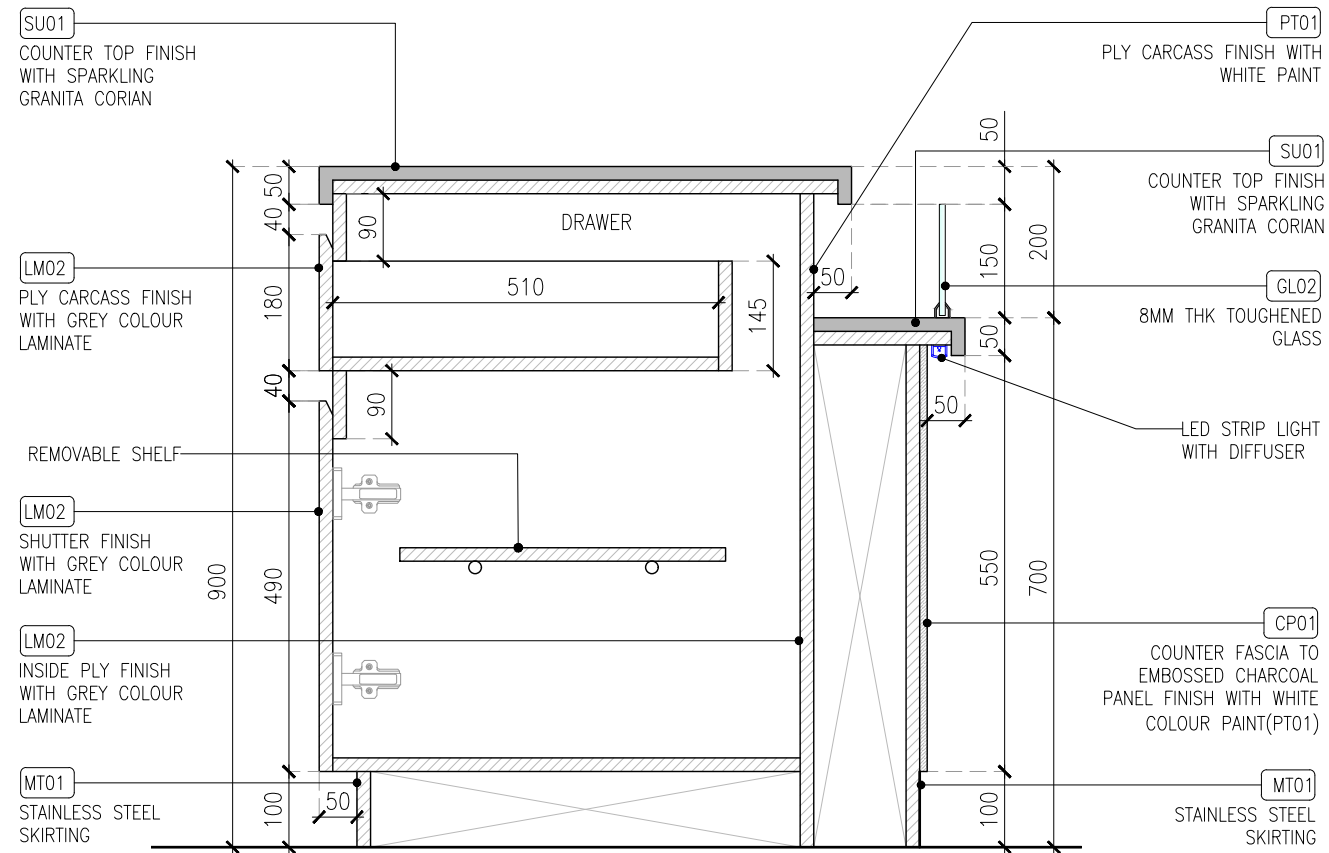


01 SECTION -01
04DE-402 1:10

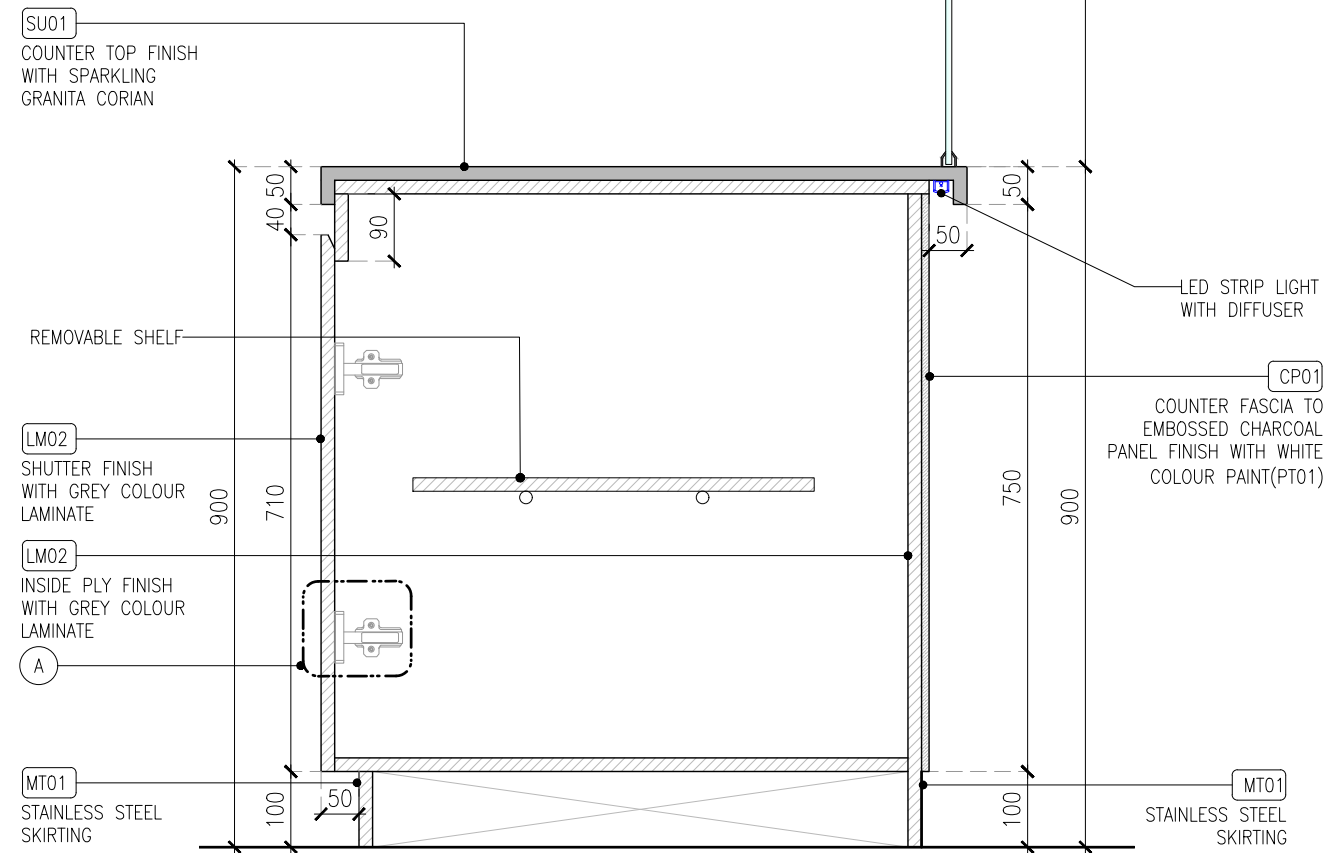


02 SECTION -02
04DE-402 1:10

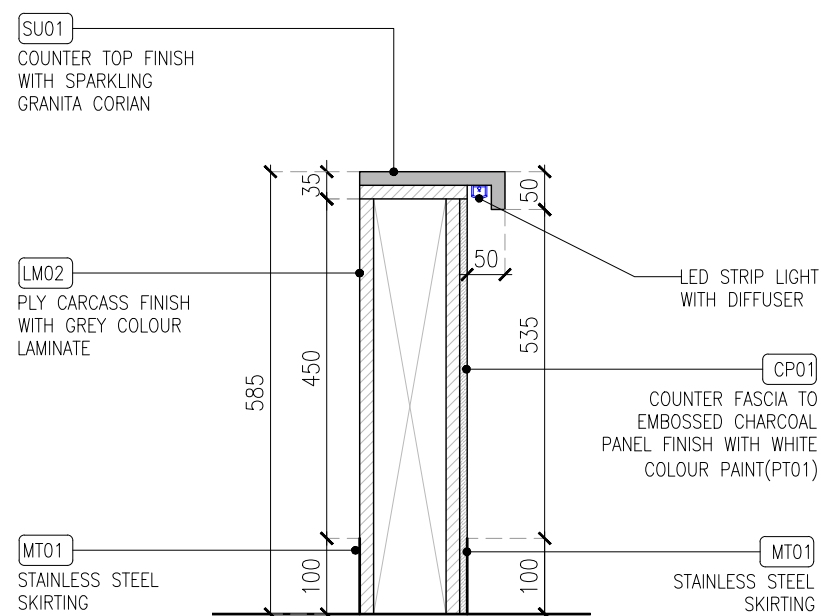

03 SECTION -03
04DE-402 1:10

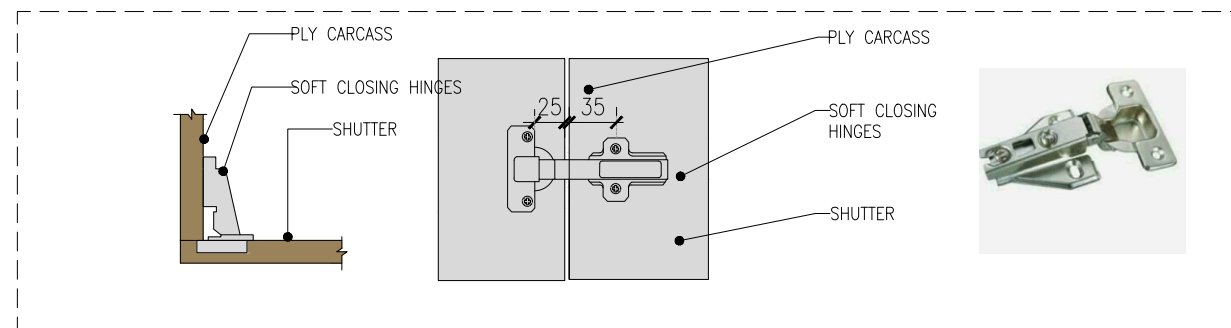

DETAIL A: STAINLESS STEEL HINGE FIXING DETAIL

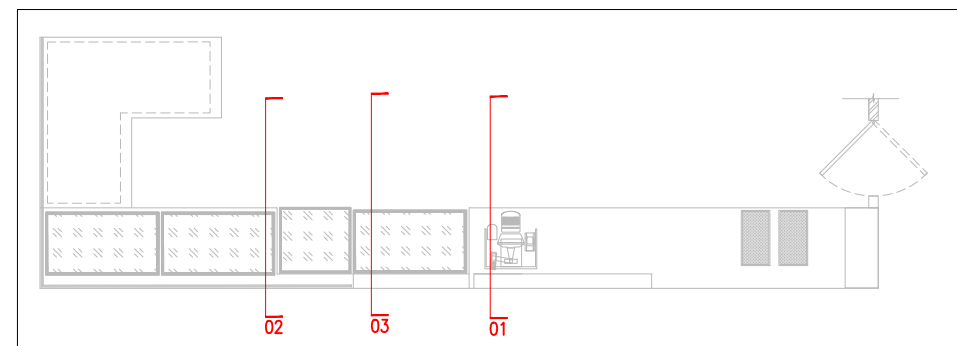

KEY PLAN

C01 01.03.24 GOOD FOR CONSTRUCTION HOD NM
REV DATE DESCRIPTION DRN CHK







PROJECT
FF-025
MILIE COOKIES
HYDERABAD AIRPORT

DRAWING TITLE
J01-FRONT COUNTER DETAIL PART-C

SCALE 1:10 DATE 01.03.2024 DRAWN HOD A3 SHEET

STATUS
GOOD FOR CONSTRUCTION

ORG PROJECT NO DRAWING TYPE NUMBER REV
TFS XXXX 04DE 402 C01

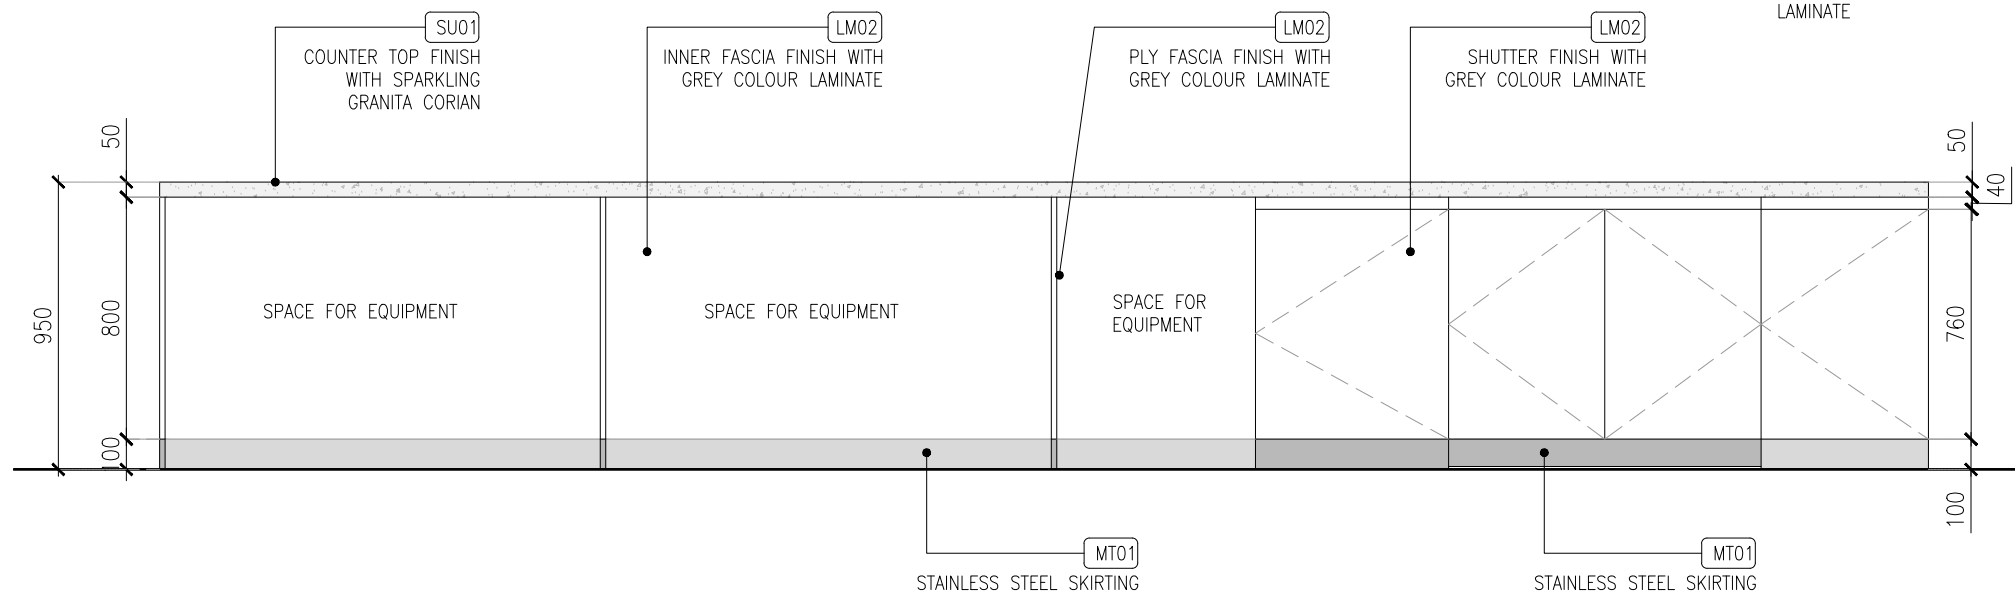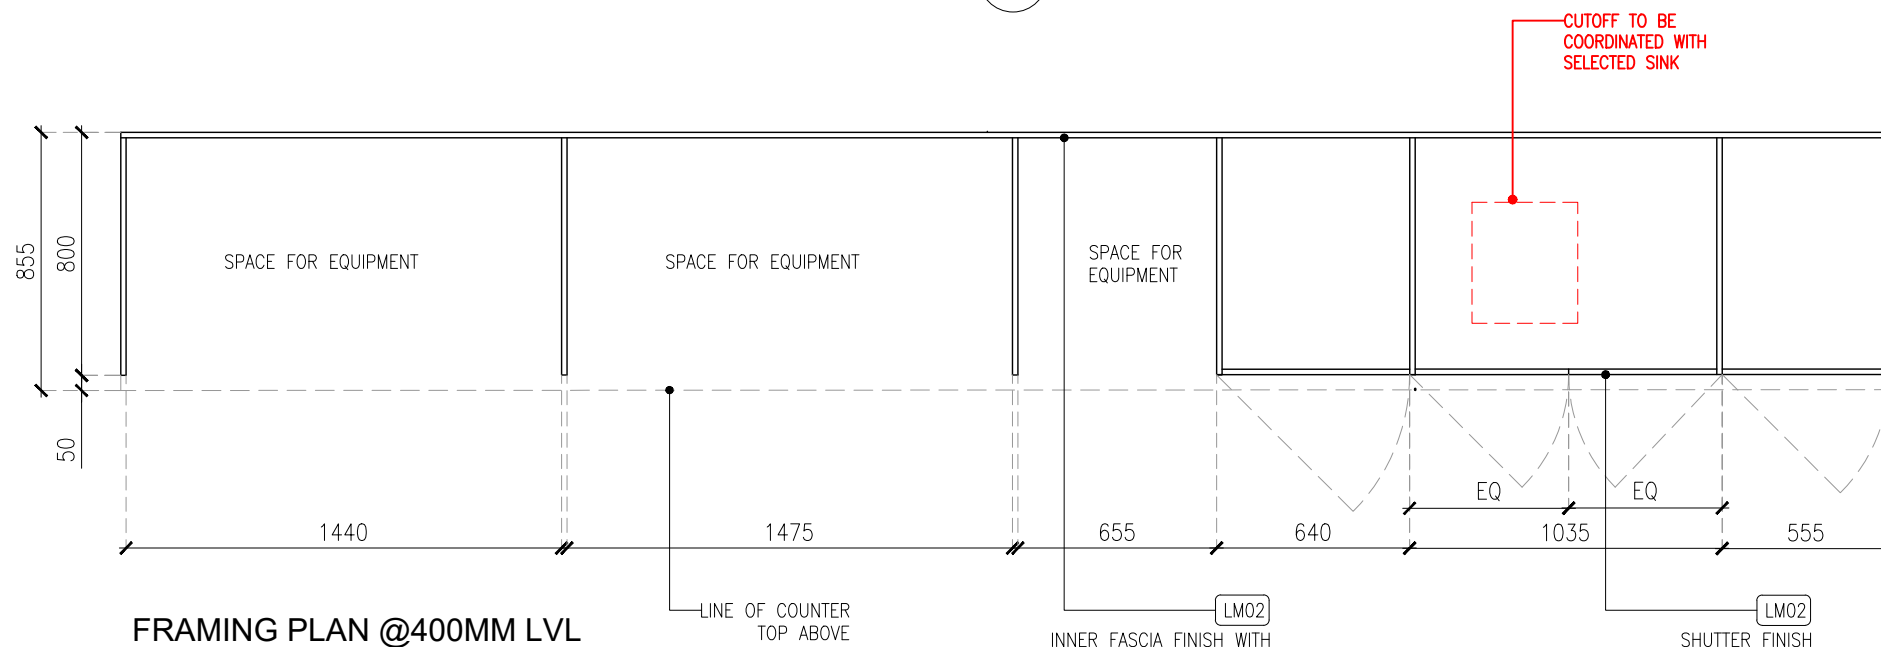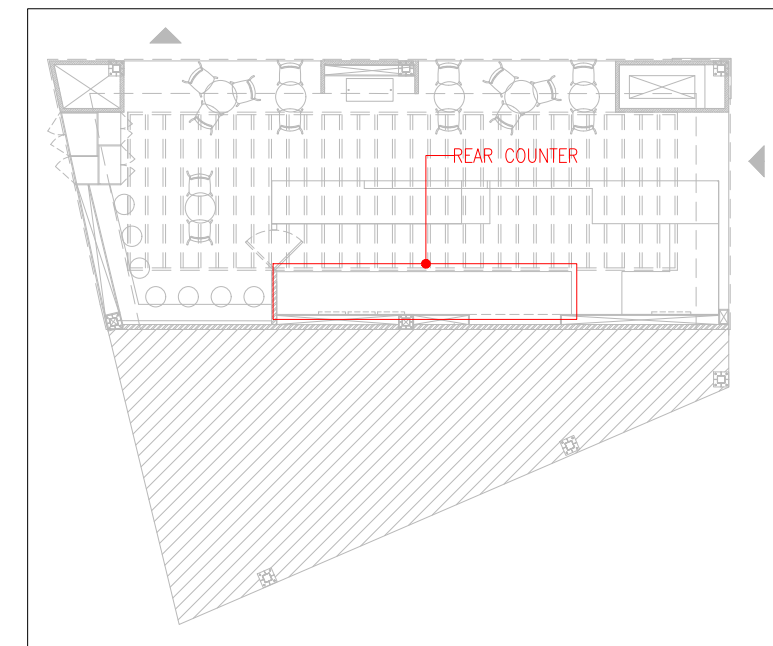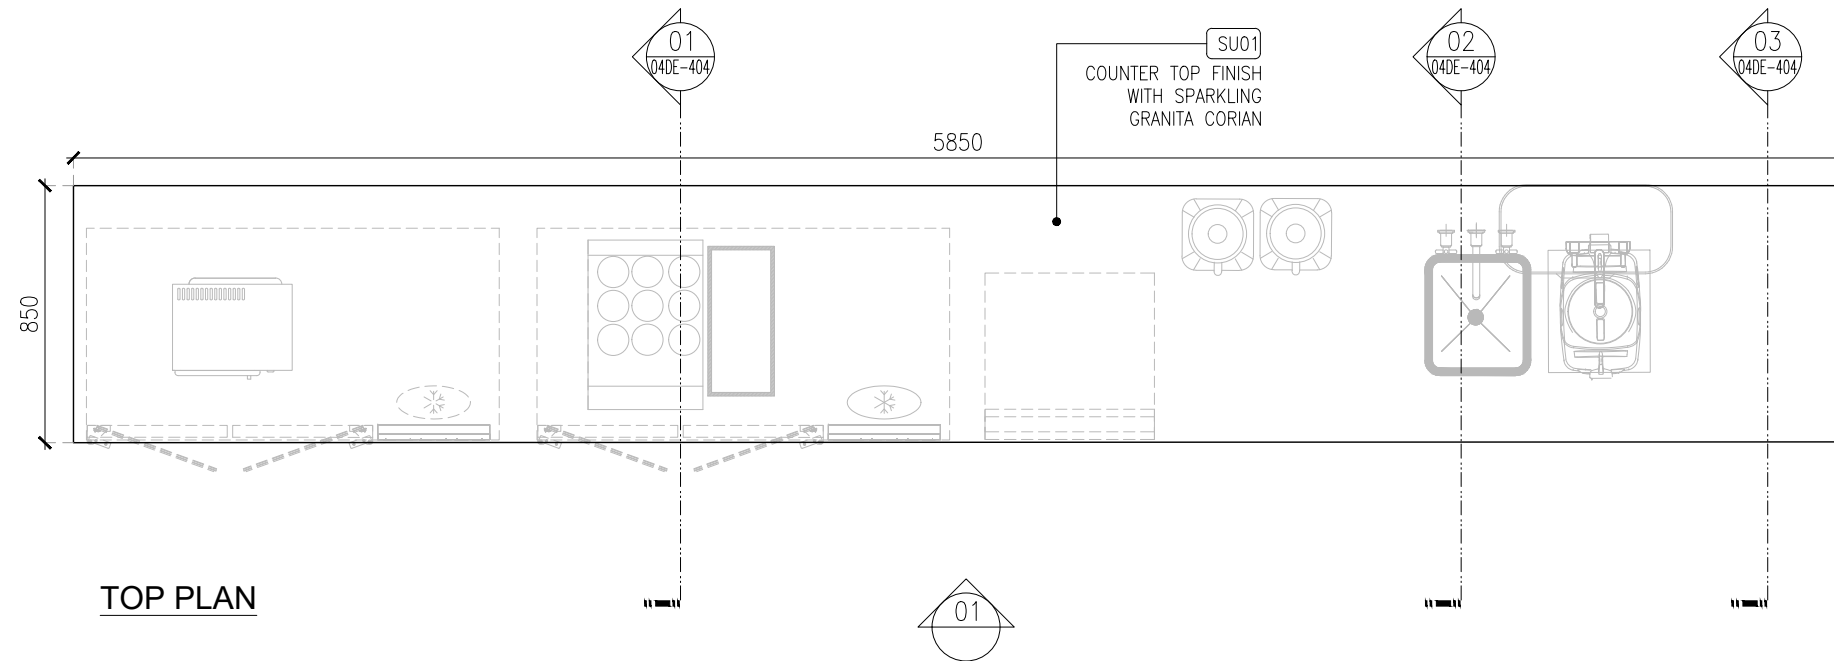

C01 01.03.24 GOOD FOR CONSTRUCTION HOD NM
REV DATE DESCRIPTION DRN CHK



PROJECT
FF-025
MILIE COOKIES
HYDERABAD AIRPORT


DRAWING TITLE
J02-REAR COUNTER-01 DETAIL
PART-A

SCALE 1:25 DATE 01.03.2024 DRAWN HOD A3 SHEET


STATUS
GOOD FOR CONSTRUCTION

ORG PROJECT NO DRAWING TYPE NUMBER REV
TFS XXXX 04DE 403 C01


01 J02-REAR COUNTER-01 DETAIL PART-A
04DE-403 1:25

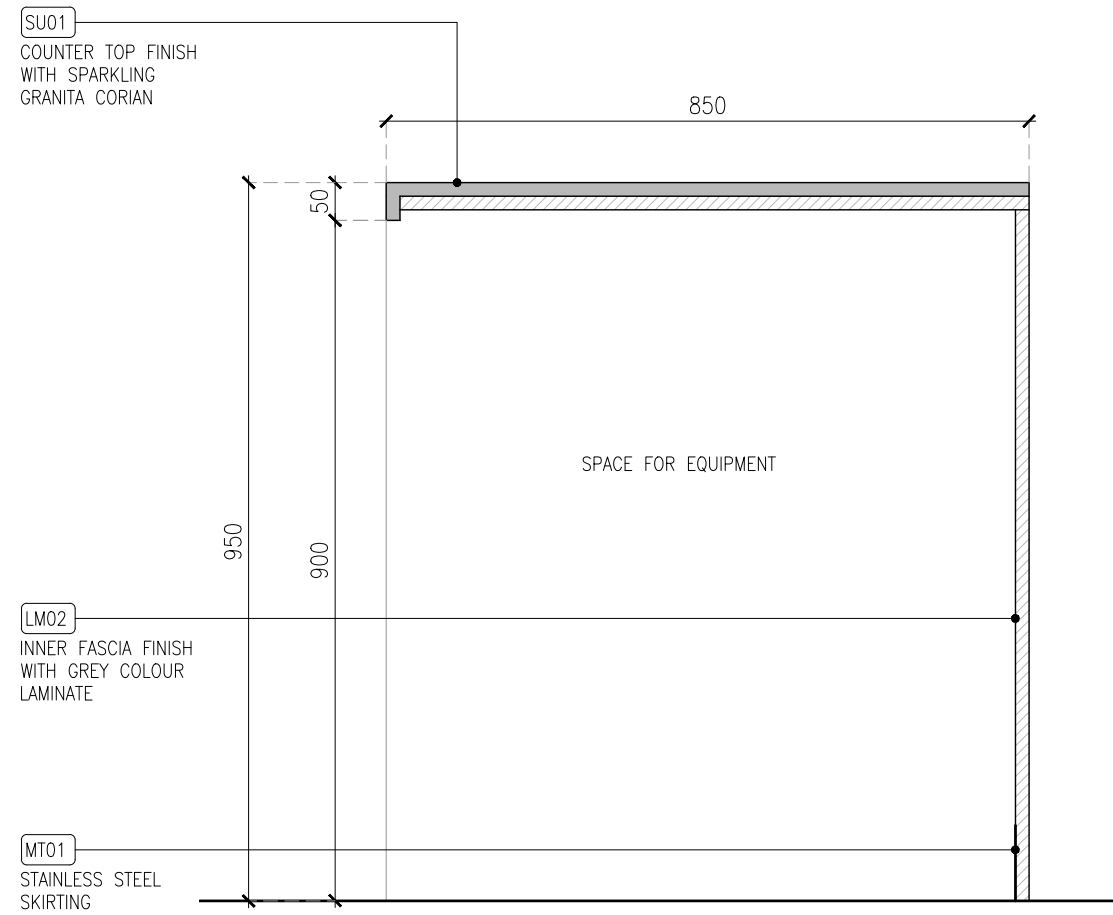


01 SECTION-01
04DE-404 1:10

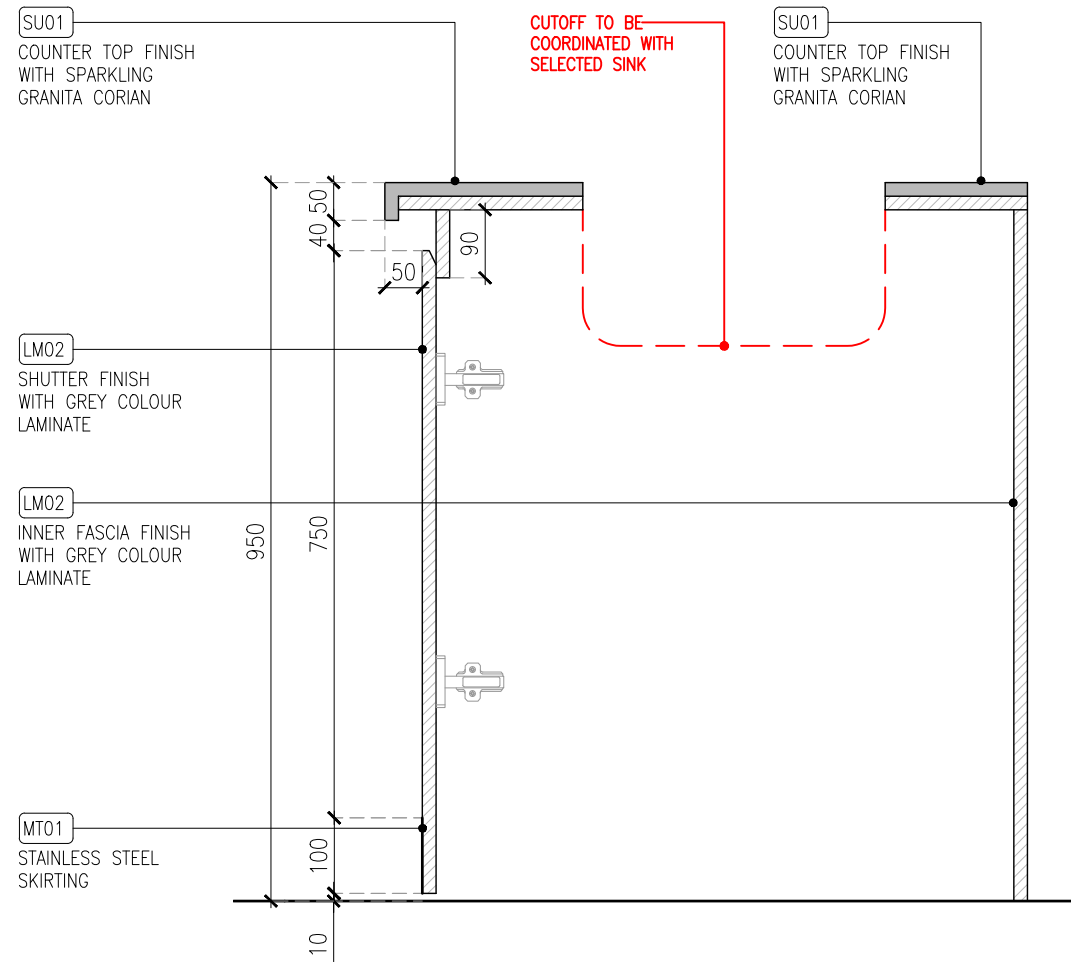

02 SECTION-02
04DE-404 1:10

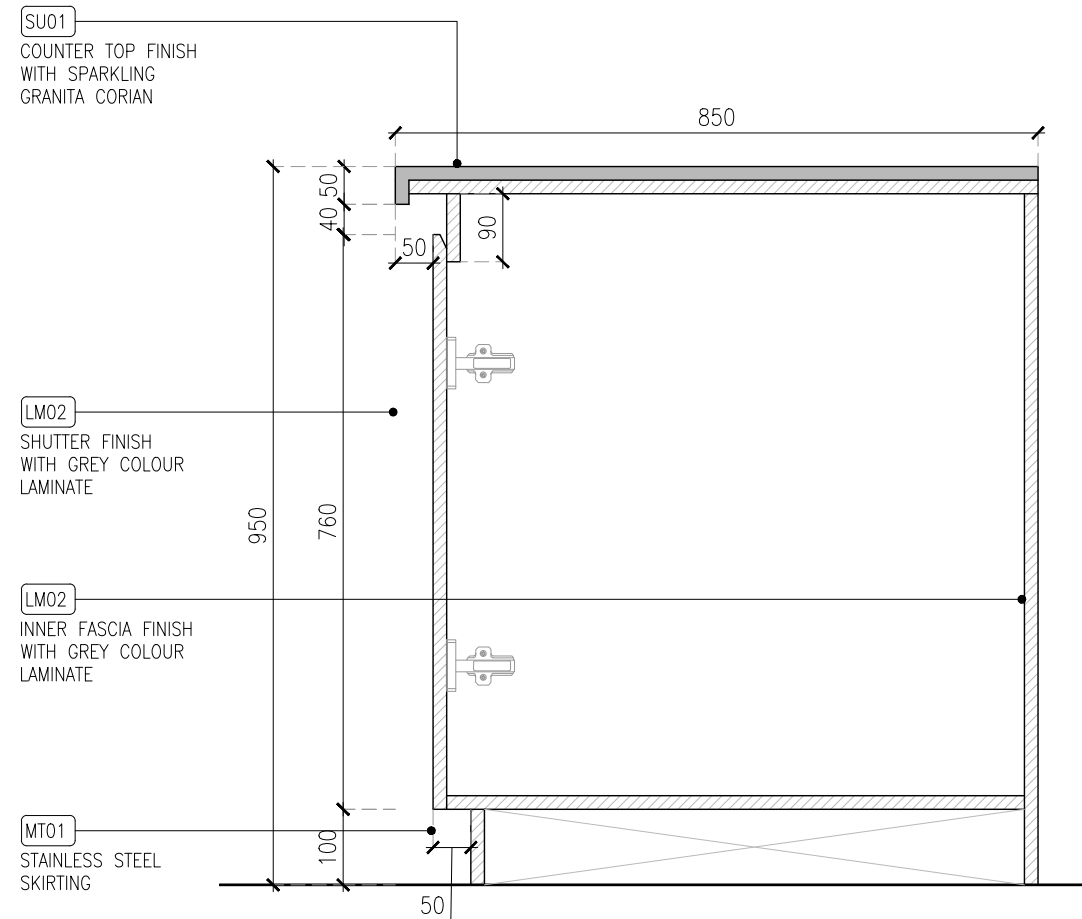

03 SECTION-03
04DE-404 1:10

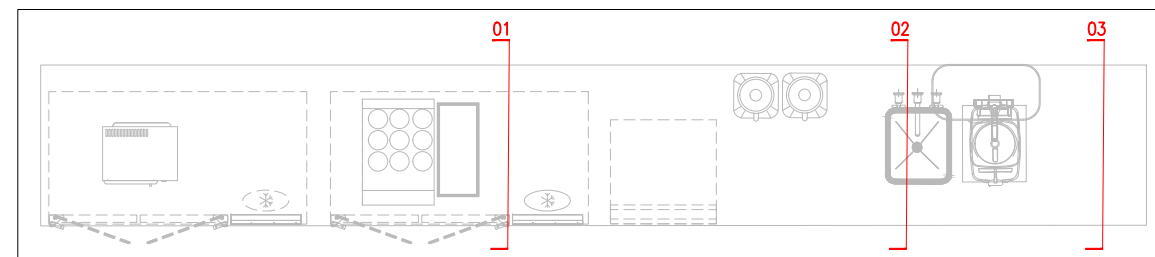

KEY PLAN

REV	DATE	DESCRIPTION	HOD	NM
C01	01.03.24	GOOD FOR CONSTRUCTION		
			DRN	CHK




PROJECT
FF-025
MILIE COOKIES
HYDERABAD AIRPORT

DRAWING TITLE
J02-REAR COUNTER-01 DETAIL
PART-B


SCALE 1:10 DATE 01.03.2024 DRAWN HOD A3 SHEET

STATUS
GOOD FOR CONSTRUCTION


ORG PROJECT NO DRAWING TYPE NUMBER REV
TFS XXXX 04DE 404 C01

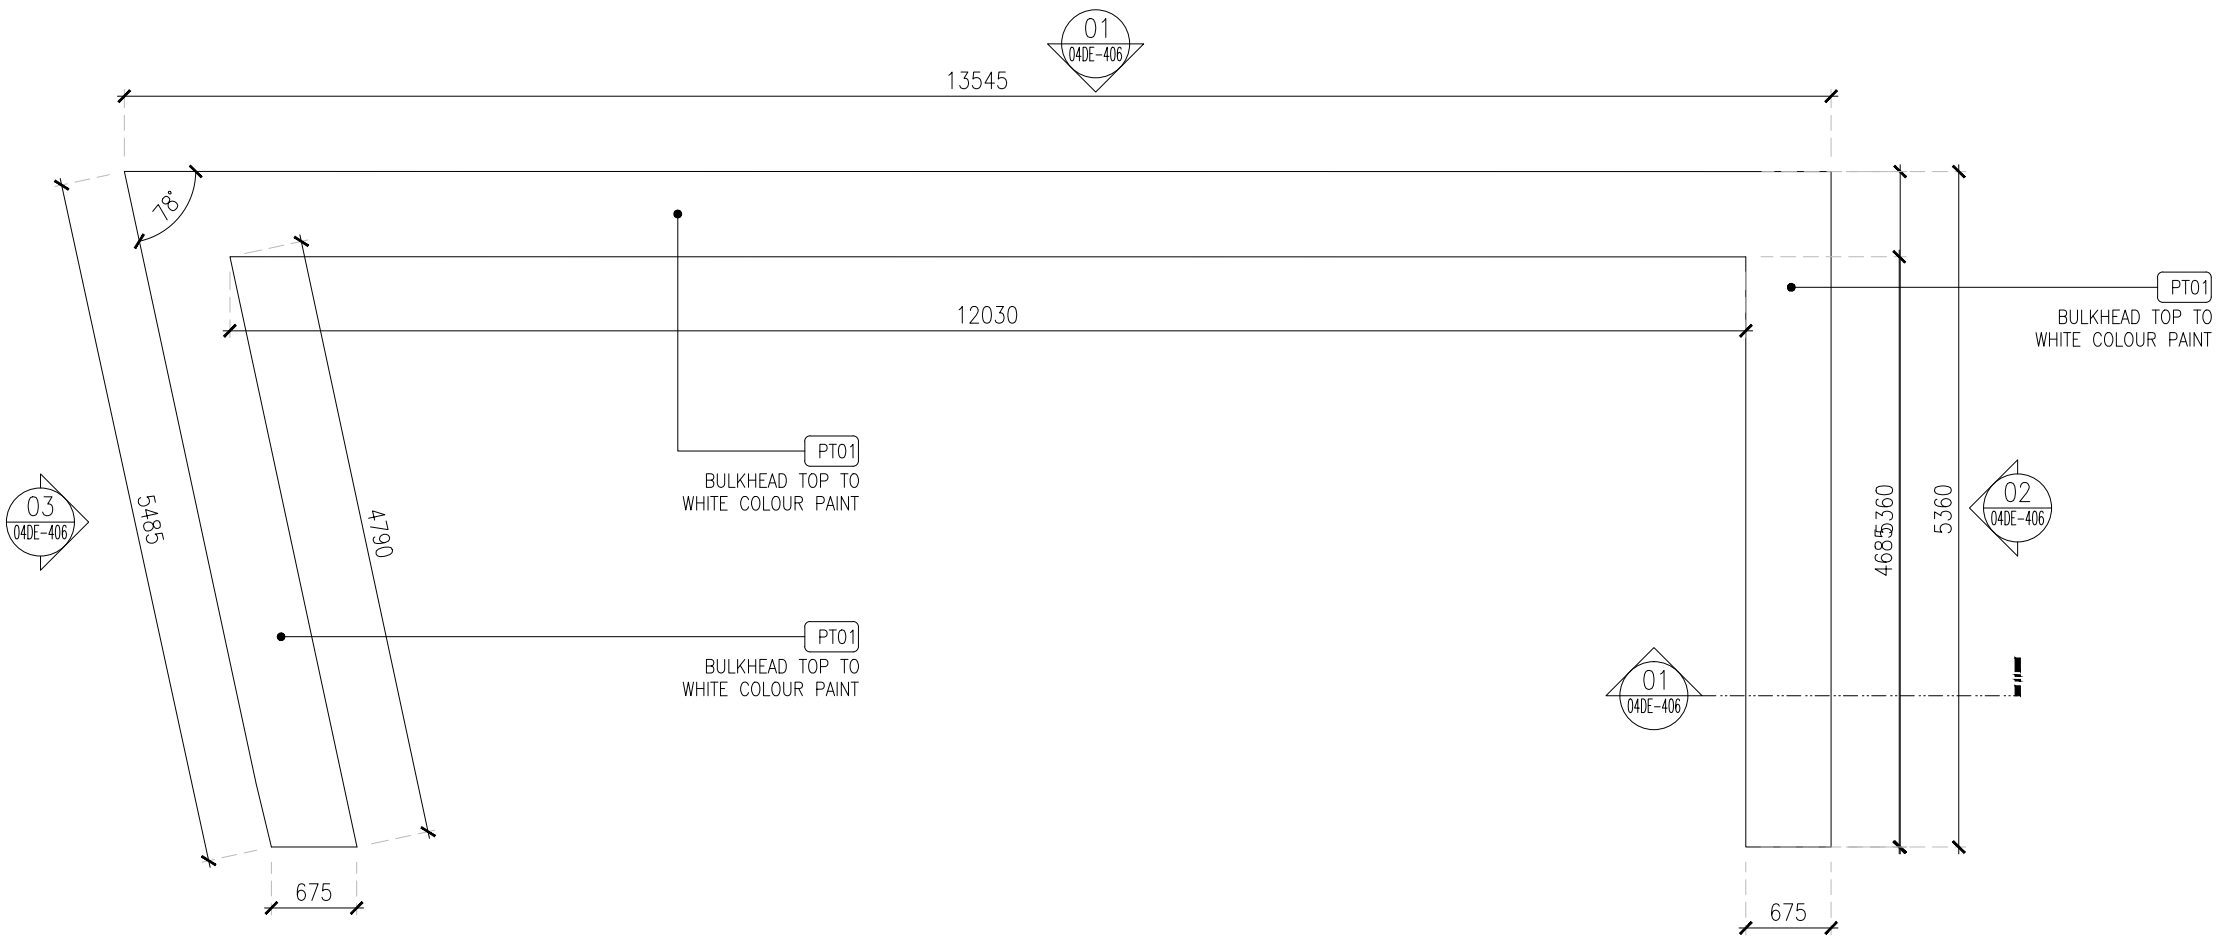

TOP PLAN

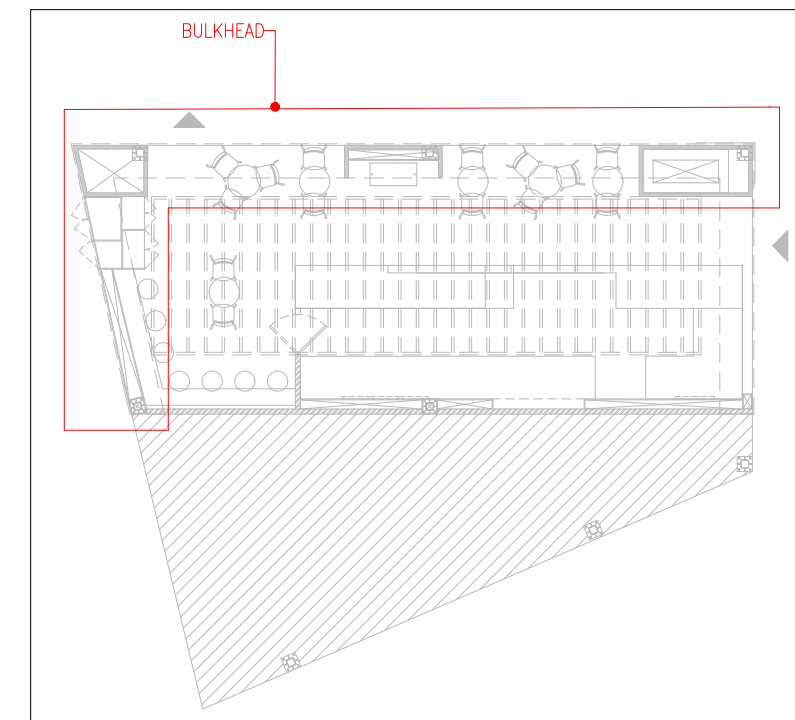

KEY PLAN

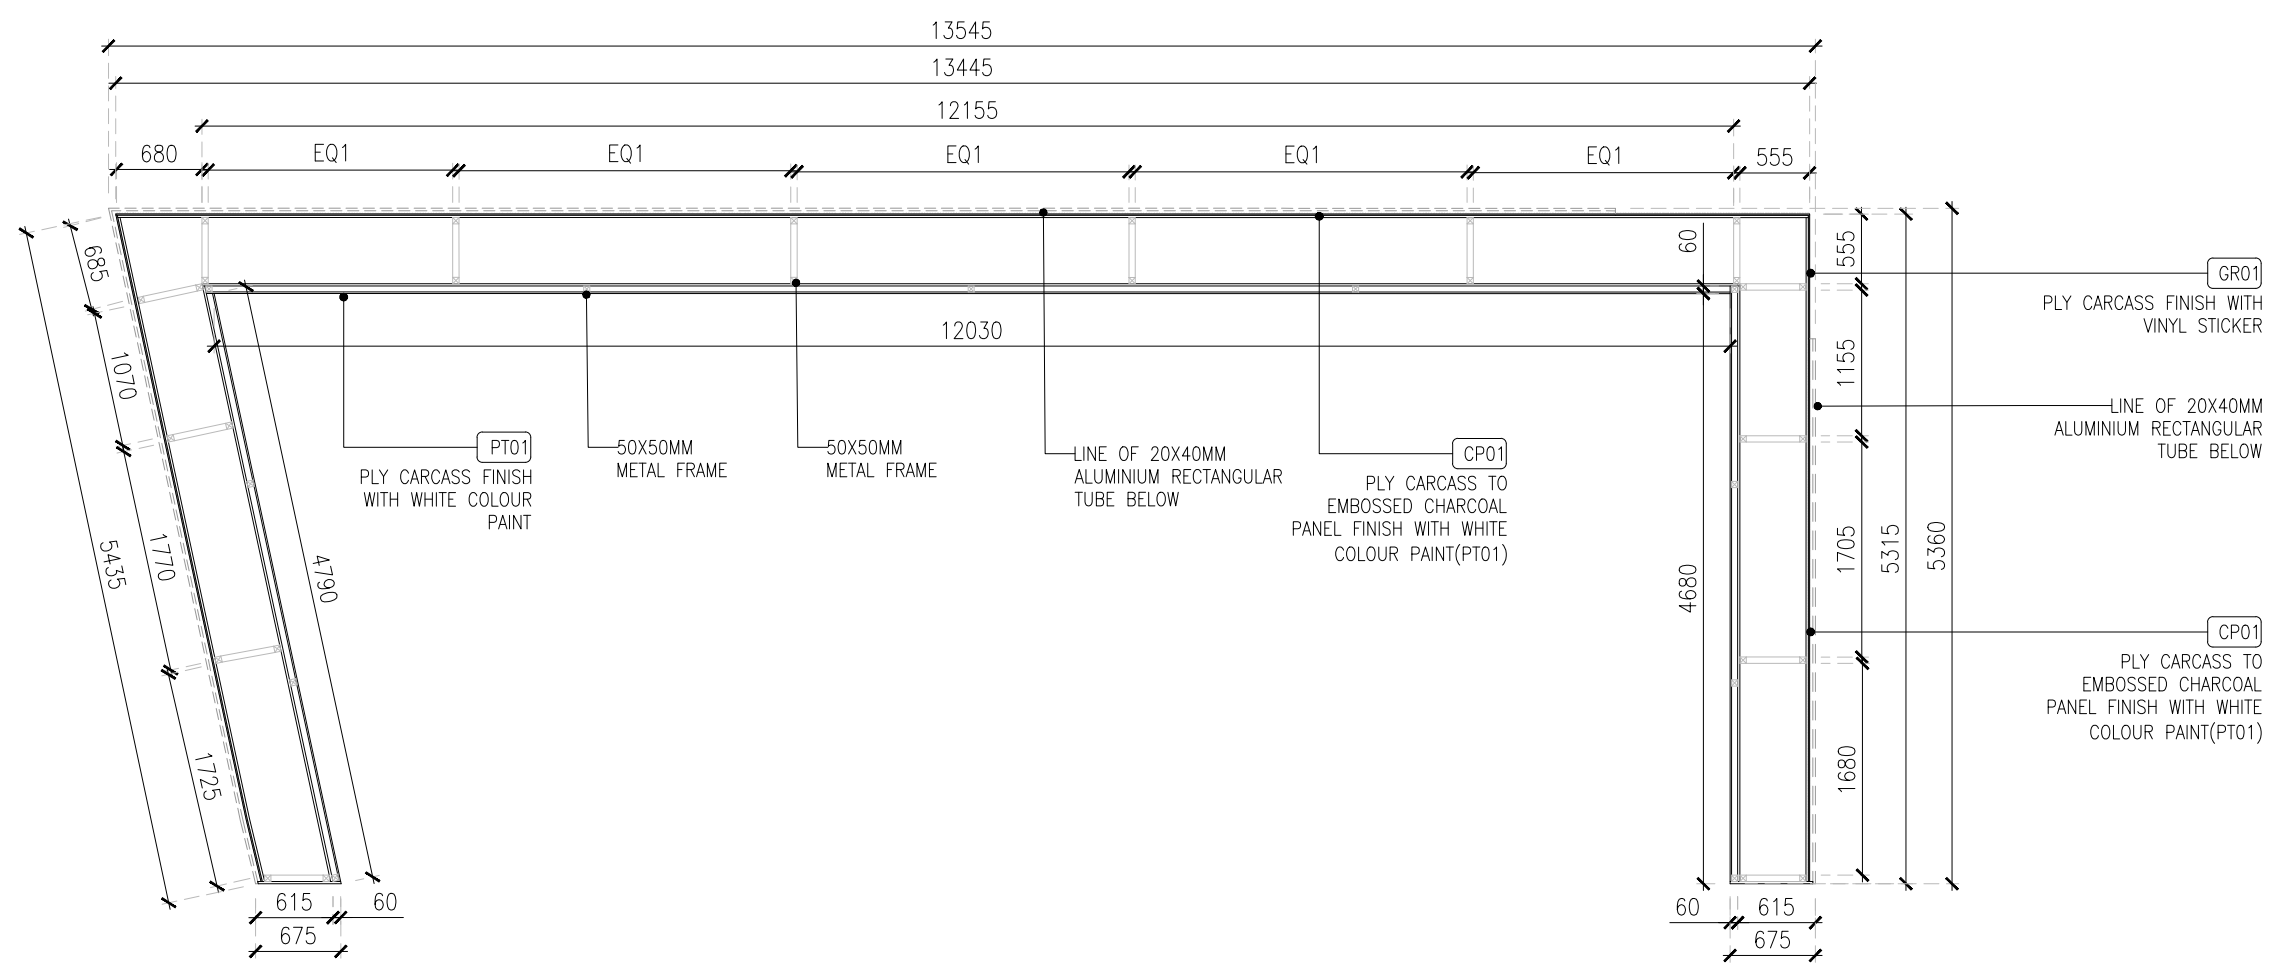

FRAMING PLAN @ 500MM LVL

01
04DE-405
1:40

J03 - BULKHEAD DETAIL-PART:A

C01	01.03.24	GOOD FOR CONSTRUCTION	HOD NM
REV	DATE	DESCRIPTION	DRN CHK




PROJECT
FF-025
MILIE COOKIES
HYDERABAD AIRPORT

DRAWING TITLE
J03-BULKHEAD DETAIL-PART:A


SCALE 1:50 DATE 01.03.2024 DRAWN HOD A3 SHEET

STATUS
GOOD FOR CONSTRUCTION


ORG	PROJECT NO	DRAWING TYPE	NUMBER	REV
TFS	XXXX	04DE	405	C01

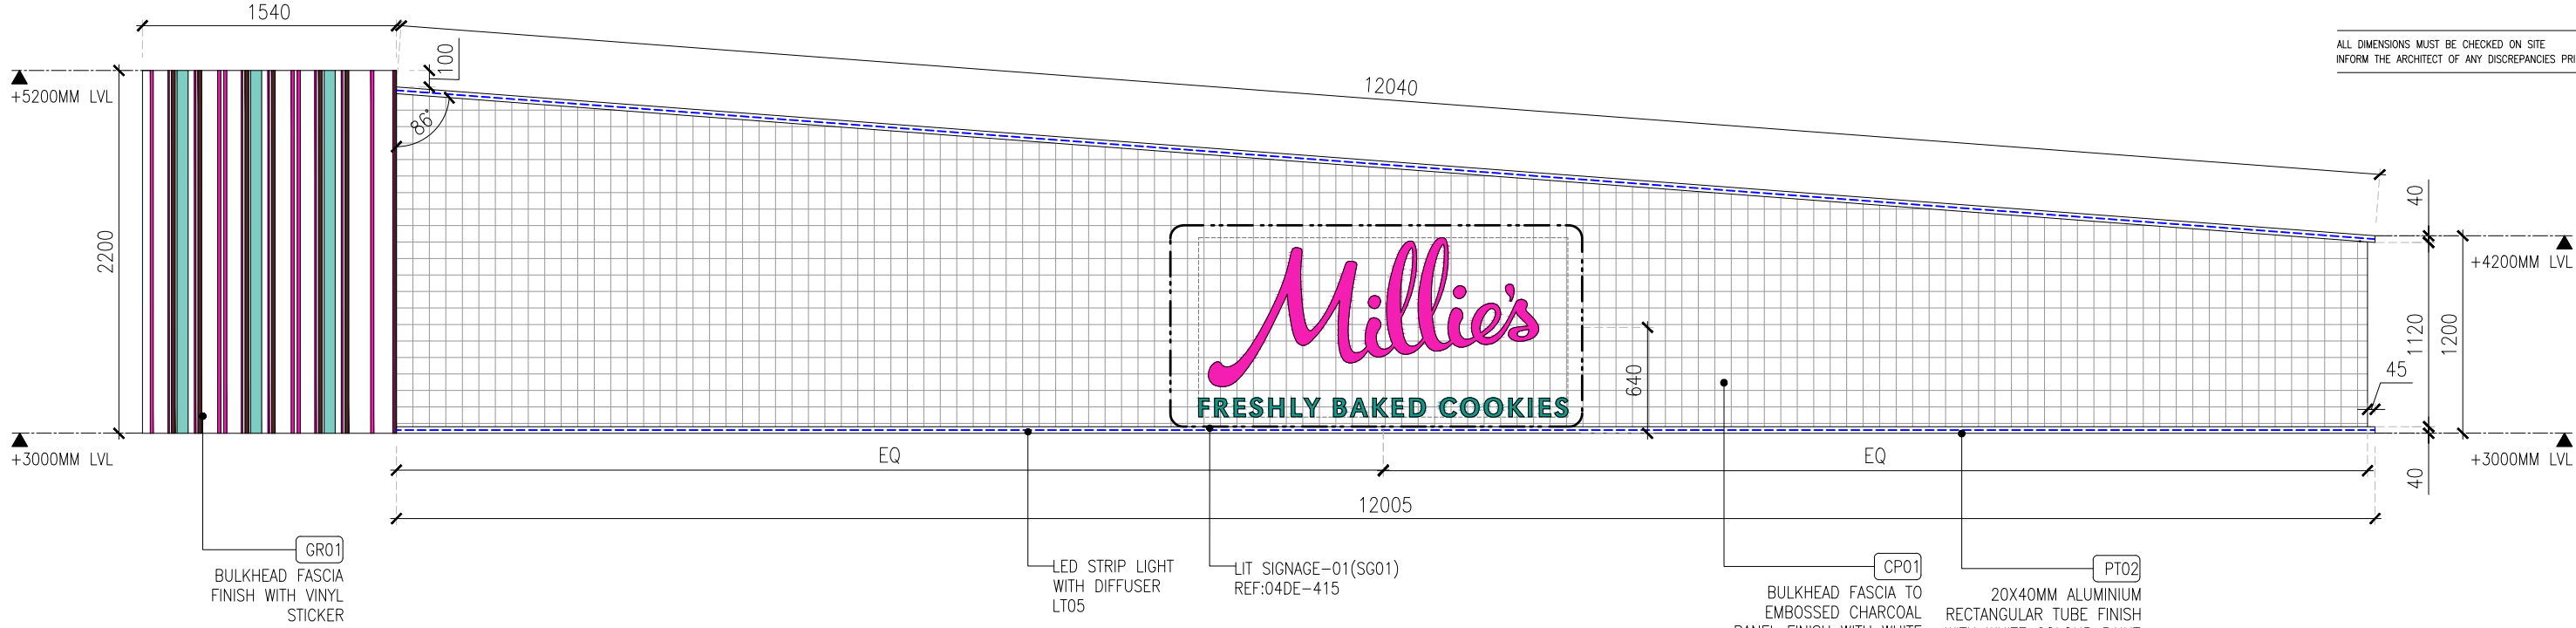


01 ELEVATION -01
04DE-406 1:40

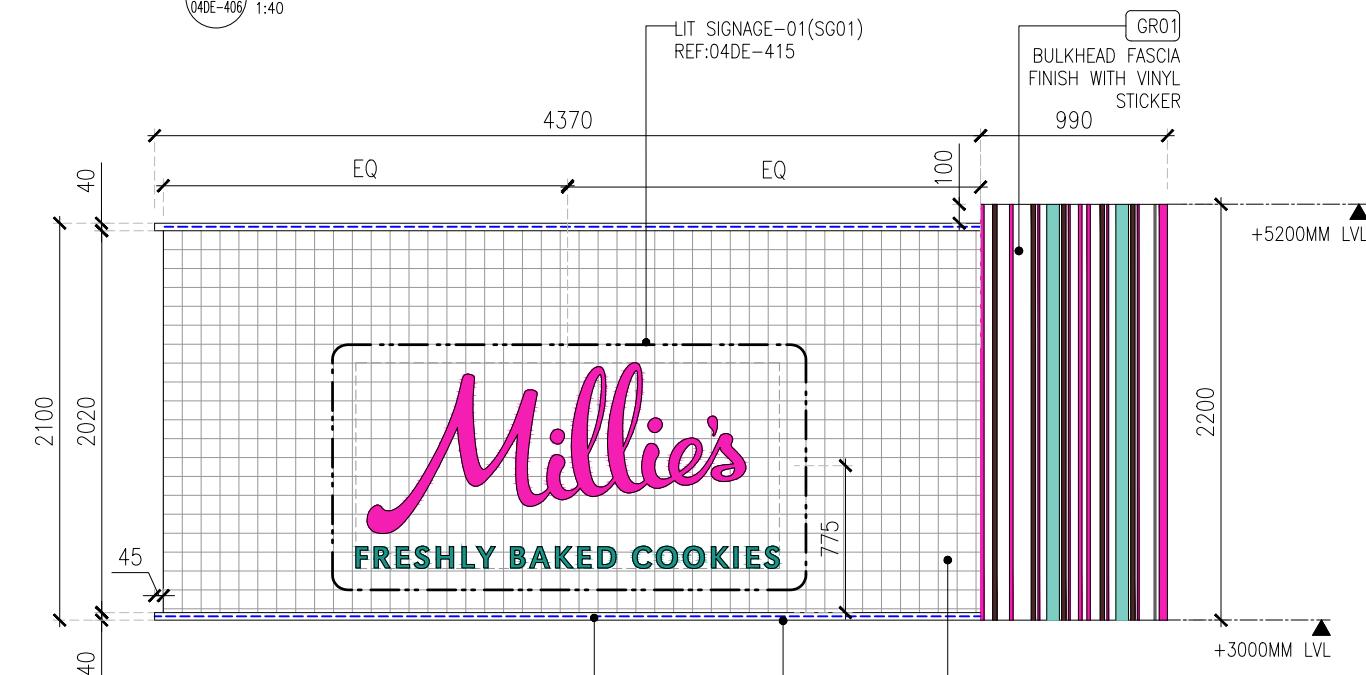


02 ELEVATION -02
04DE-406 1:40

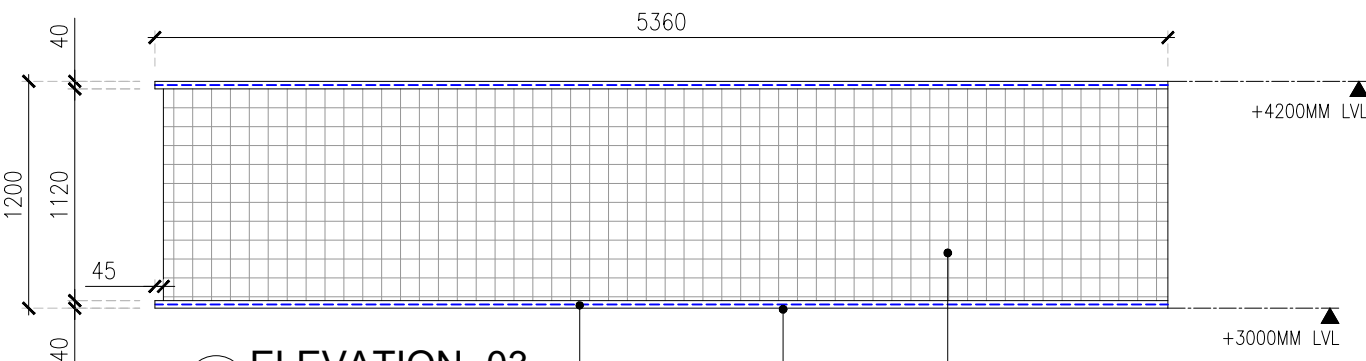


03 ELEVATION -03
04DE-406 1:40

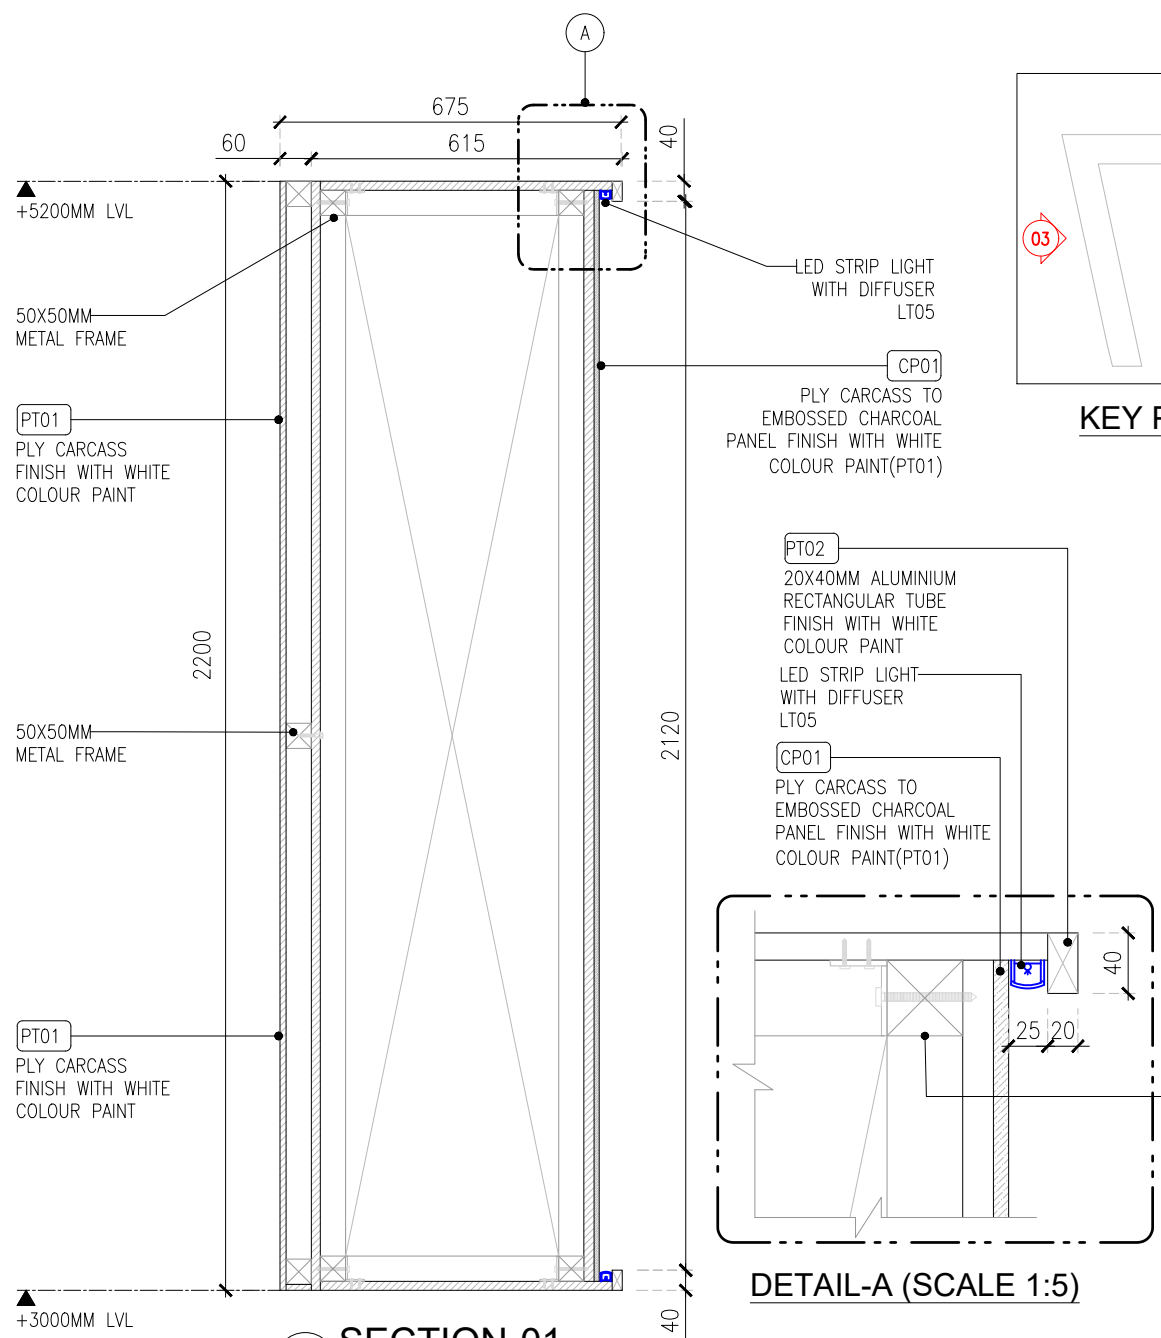

04 SECTION-01
04DE-406 1:15

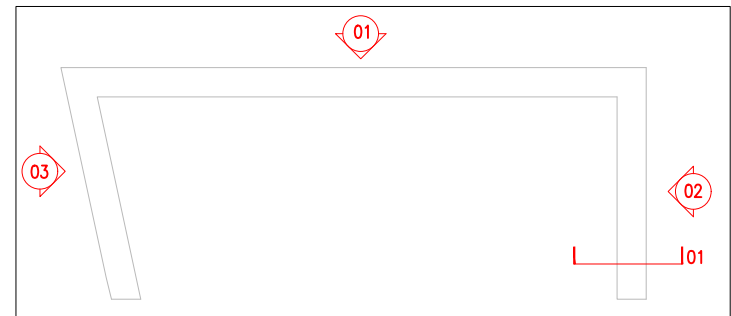

KEY PLAN

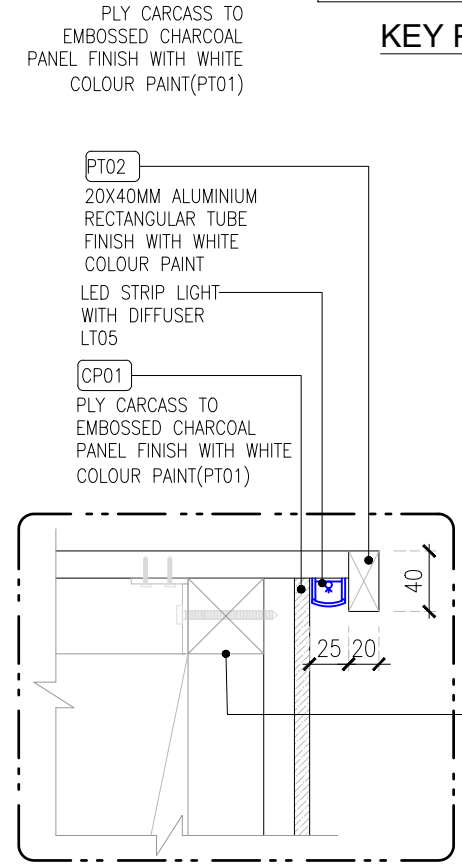

DETAIL-A (SCALE 1:5)

C01	01.03.24	GOOD FOR CONSTRUCTION	HOD	NM
REV	DATE	DESCRIPTION	DRN	CHK




PROJECT
FF-025
MILIE COOKIES
HYDERABAD AIRPORT

DRAWING TITLE
J03-BULKHEAD DETAIL-PART:B


SCALE AS MENTIONED DATE 01.03.2024 DRAWN HOD A3 SHEET

STATUS
GOOD FOR CONSTRUCTION


ORG PROJECT NO DRAWING TYPE NUMBER REV
TFS XXXX 04DE 406 C01

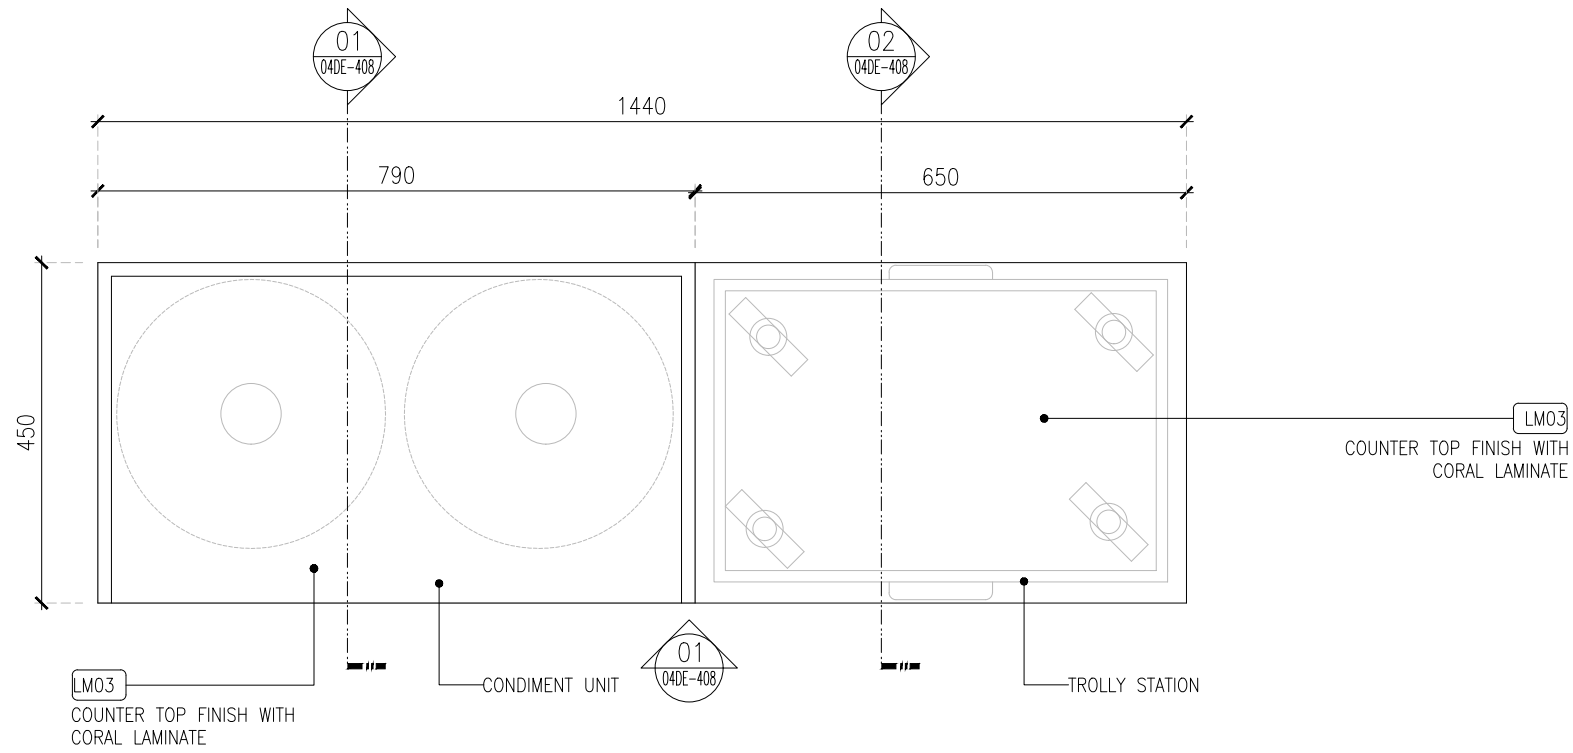

TOP PLAN

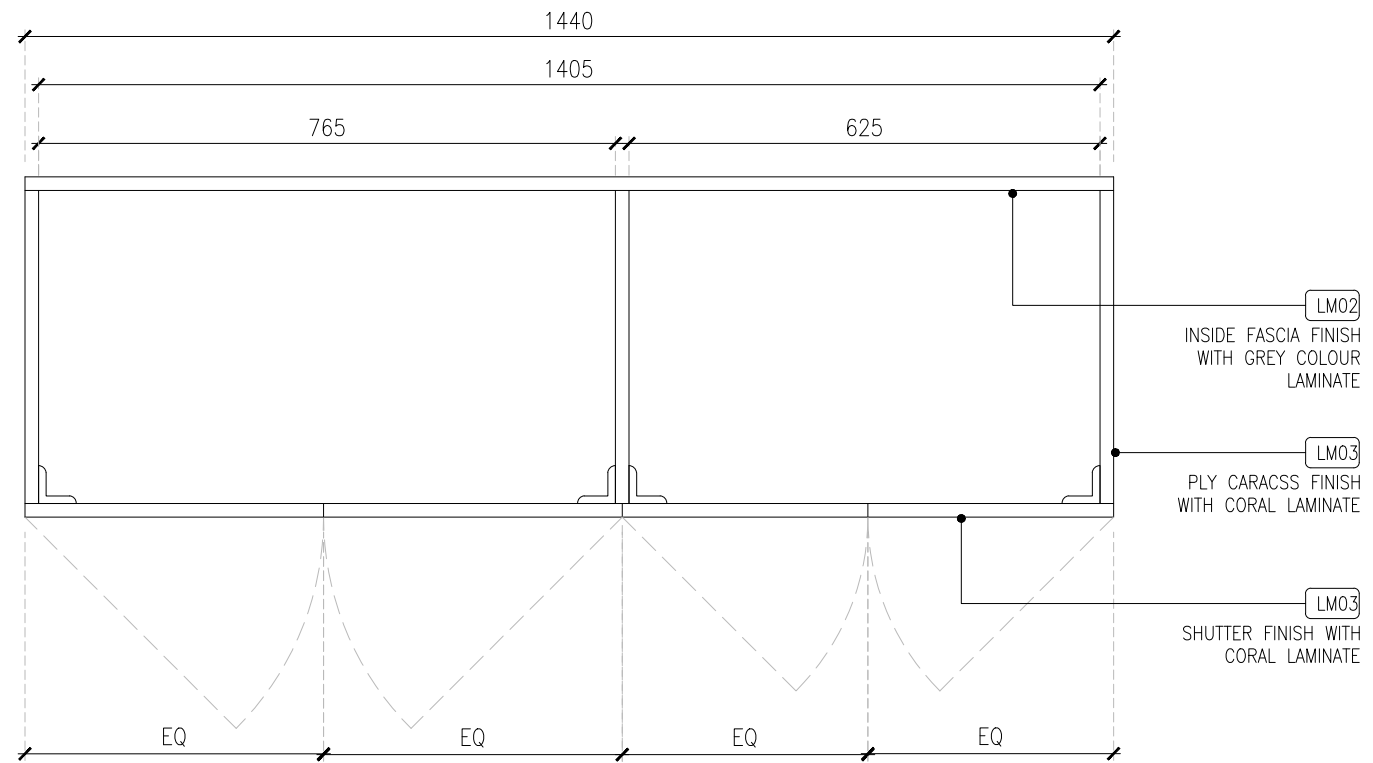

FRAMING PLAN @ 500MM LVL

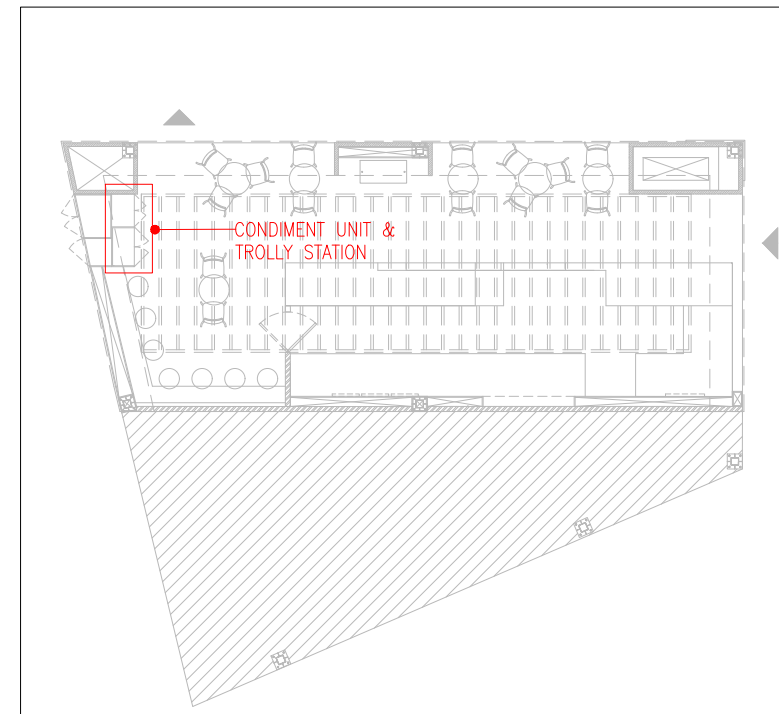

KEY PLAN

01
04DE-407 1:10 J04 -CONDIMENT UNIT & TROLLEY STATION DETAIL-PART:A

C01	01.03.24	GOOD FOR CONSTRUCTION	HOD	NM
REV	DATE	DESCRIPTION	DRN	CHK







PROJECT
FF-025
MILIE COOKIES
HYDERABAD AIRPORT

DRAWING TITLE
J04-CONDIMENT UNIT & TROLLEY STATION DETAIL-PART:A

SCALE 1:50 DATE 01.03.2024 DRAWN HOD A3 SHEET

STATUS
GOOD FOR CONSTRUCTION

ORG	PROJECT NO	DRAWING TYPE	NUMBER	REV
TFS	XXXX	04DE	407	C01

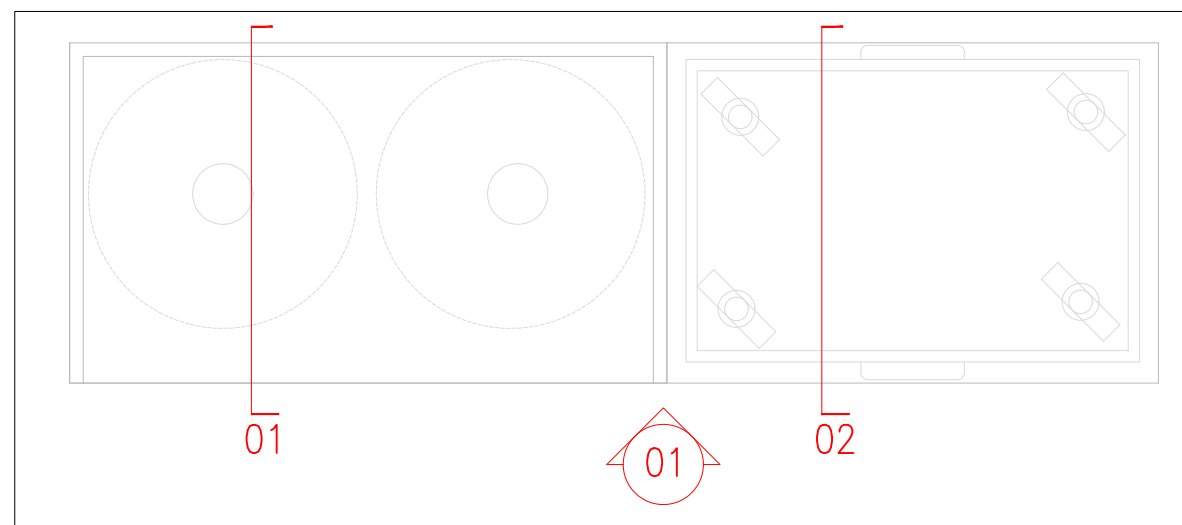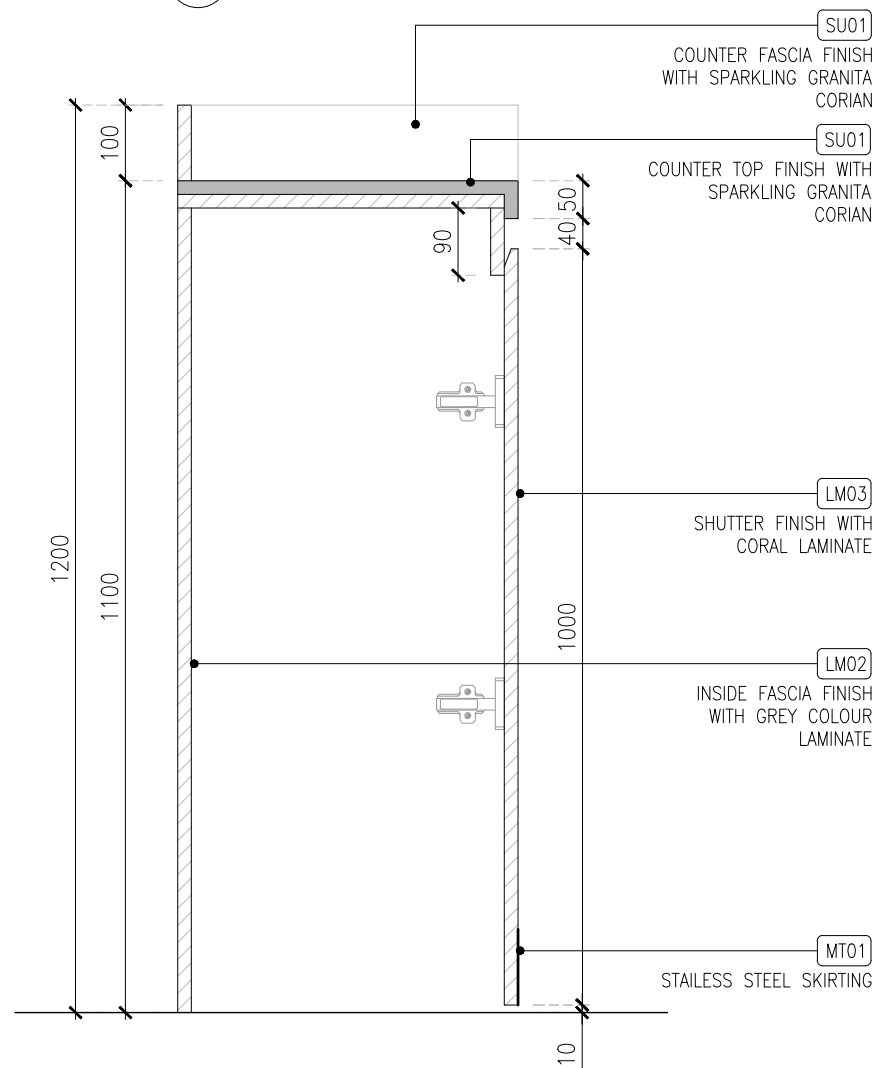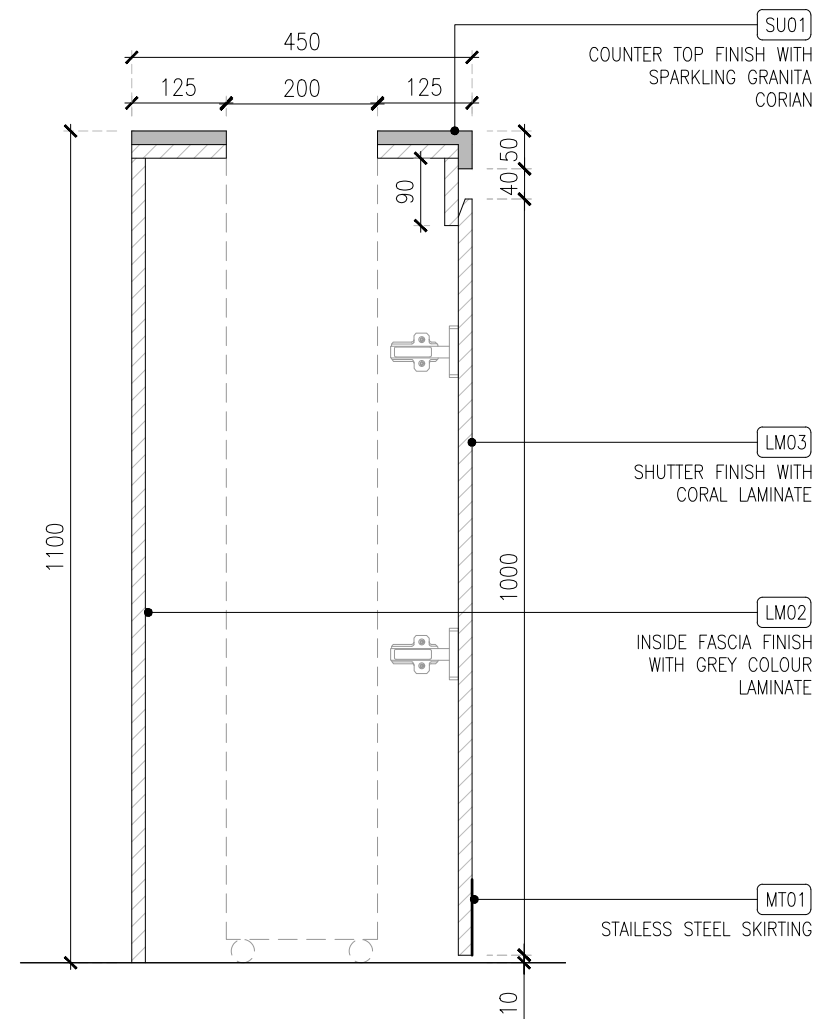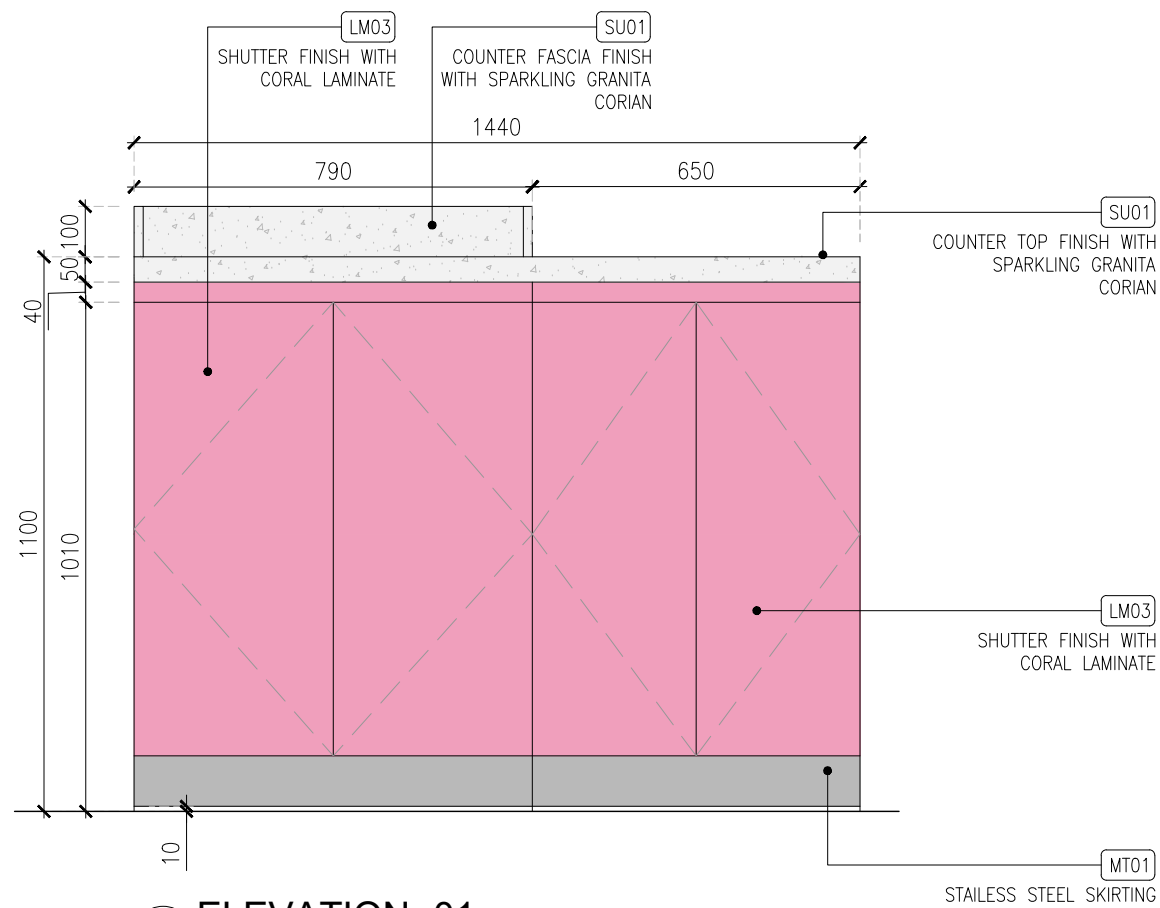

REV	DATE	DESCRIPTION	DRN	CHK	HOD	NM
C01	01.03.24	GOOD FOR CONSTRUCTION				




PROJECT
FF-025
MILIE COOKIES
HYDERABAD AIRPORT

DRAWING TITLE
J04-CONDIMENT UNIT &
TROLLY STATION DETAIL-PART:B


SCALE AS MENTIONED DATE 01.03.2024 DRAWN HOD A3 SHEET

STATUS
GOOD FOR CONSTRUCTION

ORG PROJECT NO DRAWING TYPE NUMBER REV
TFS XXXX 04DE 408 C01

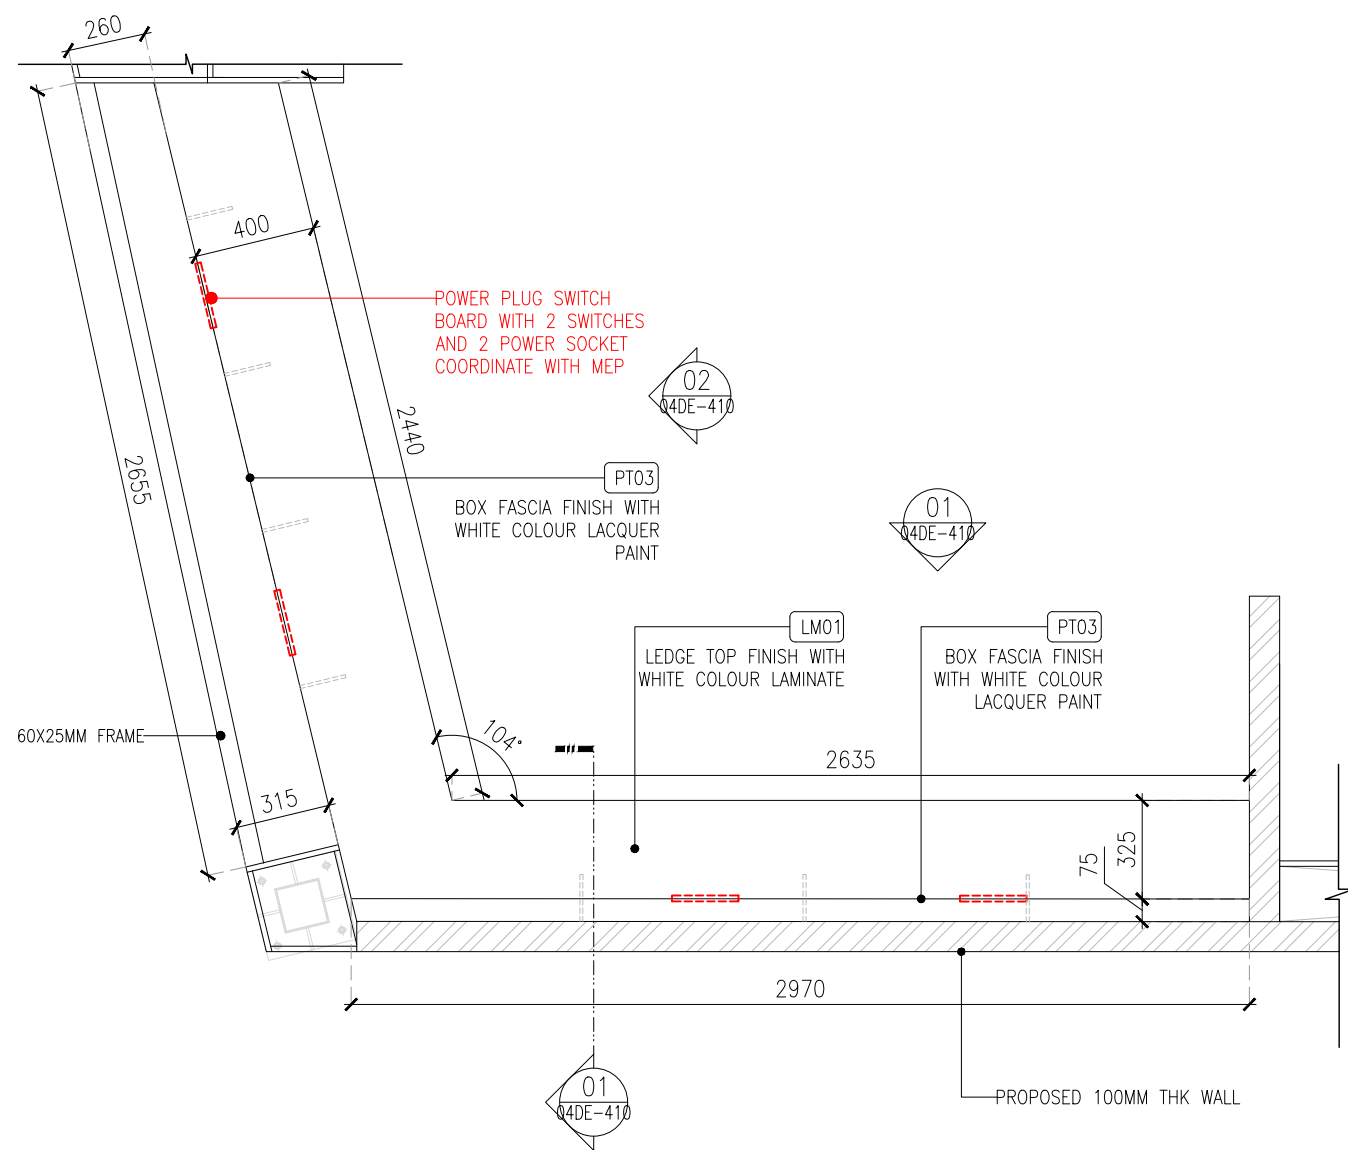


TOP PLAN

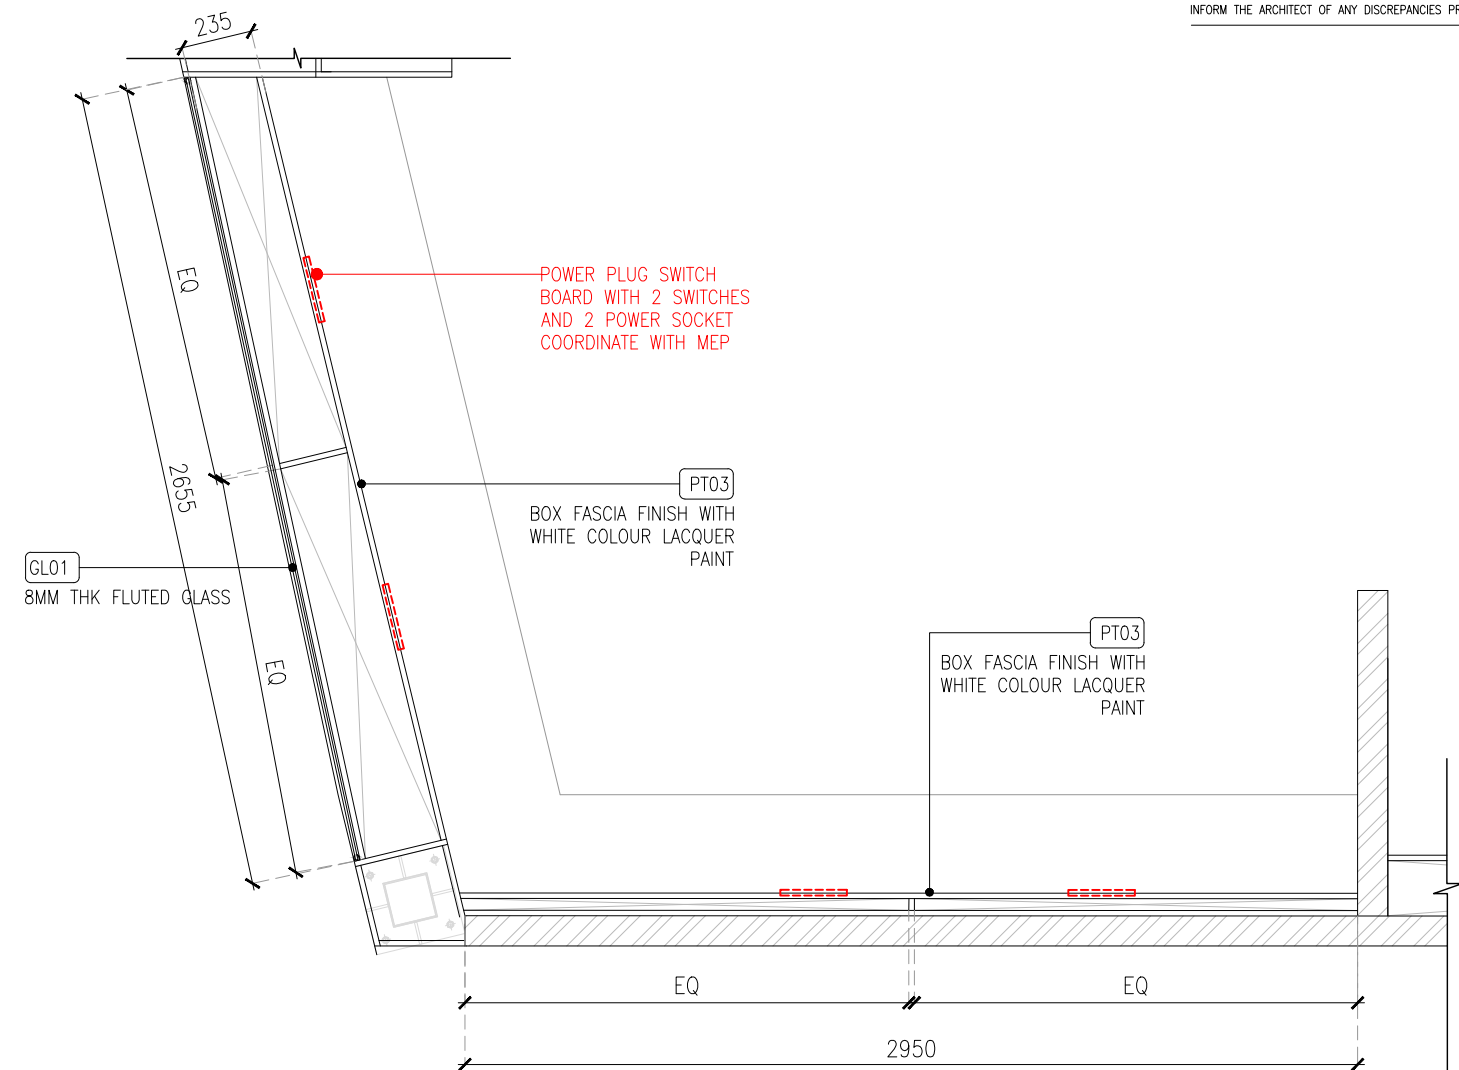

FRAMING PLAN @1200MM LVL

01 J05-LEDGE DETAIL-PART:A
04DE-409 1:25

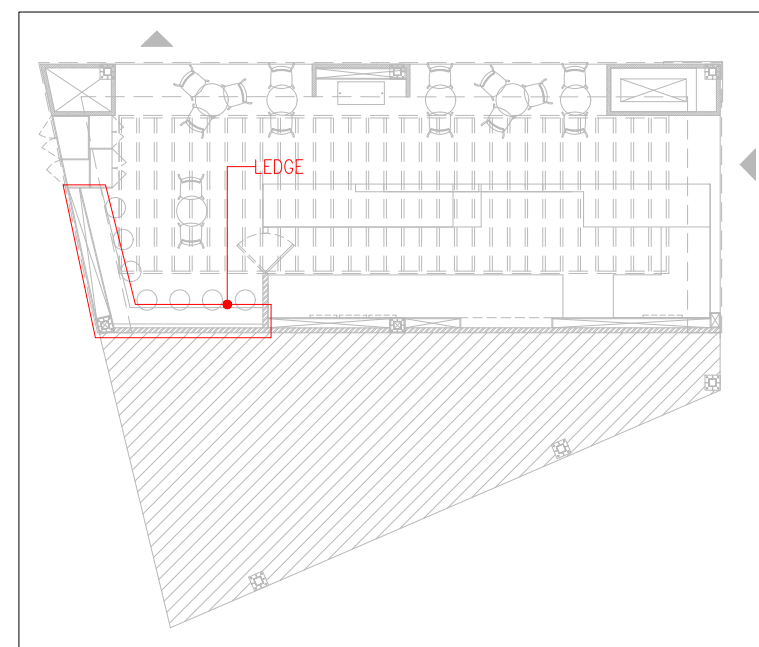

KEY PLAN

REV	DATE	DESCRIPTION	HOD	NM	DRN	CHK
C01	01.03.24	GOOD FOR CONSTRUCTION				




PROJECT
FF-025
MILIE COOKIES
HYDERABAD AIRPORT

DRAWING TITLE
J05-LEDGE DETAIL-PART:A


SCALE 1:25 DATE 01.03.2024 DRAWN HOD A3 SHEET

STATUS
GOOD FOR CONSTRUCTION


ORG	PROJECT NO	DRAWING TYPE	NUMBER	REV
TFS	XXXX	04DE	409	C01

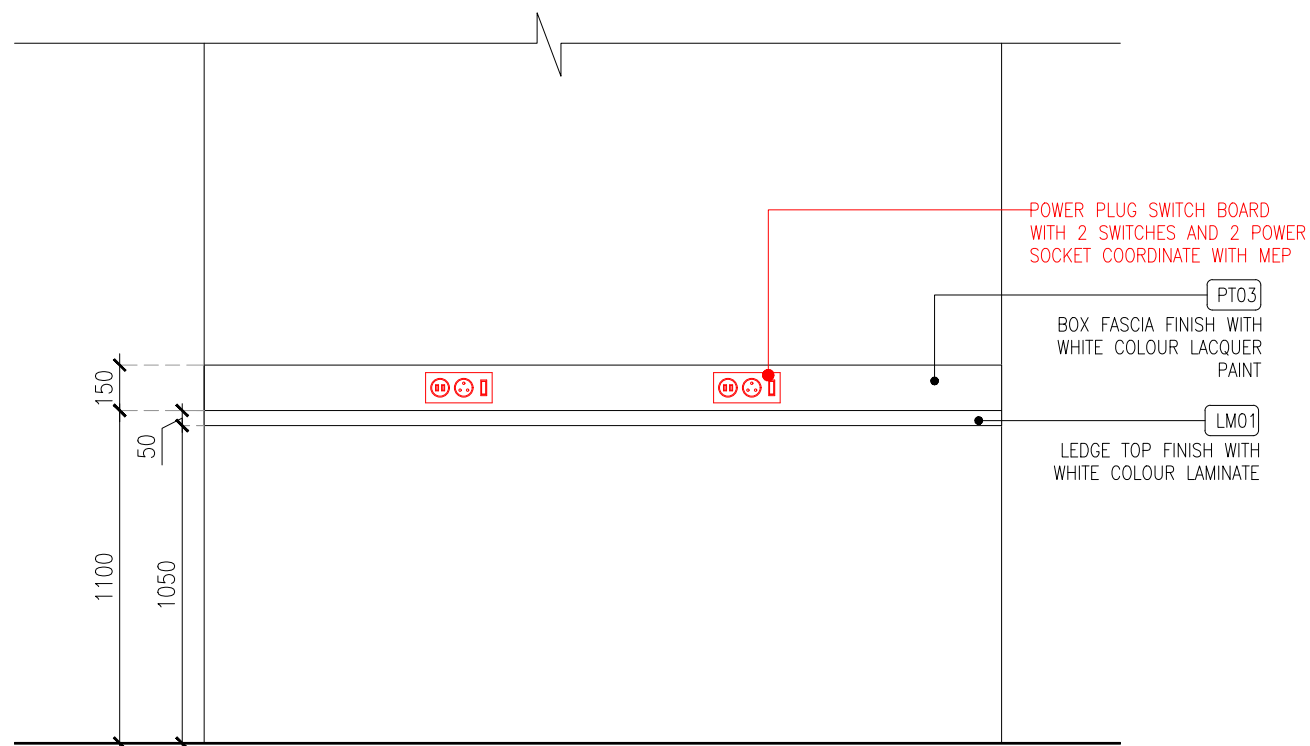


01 ELEVATION -01
04DE-410 1:25

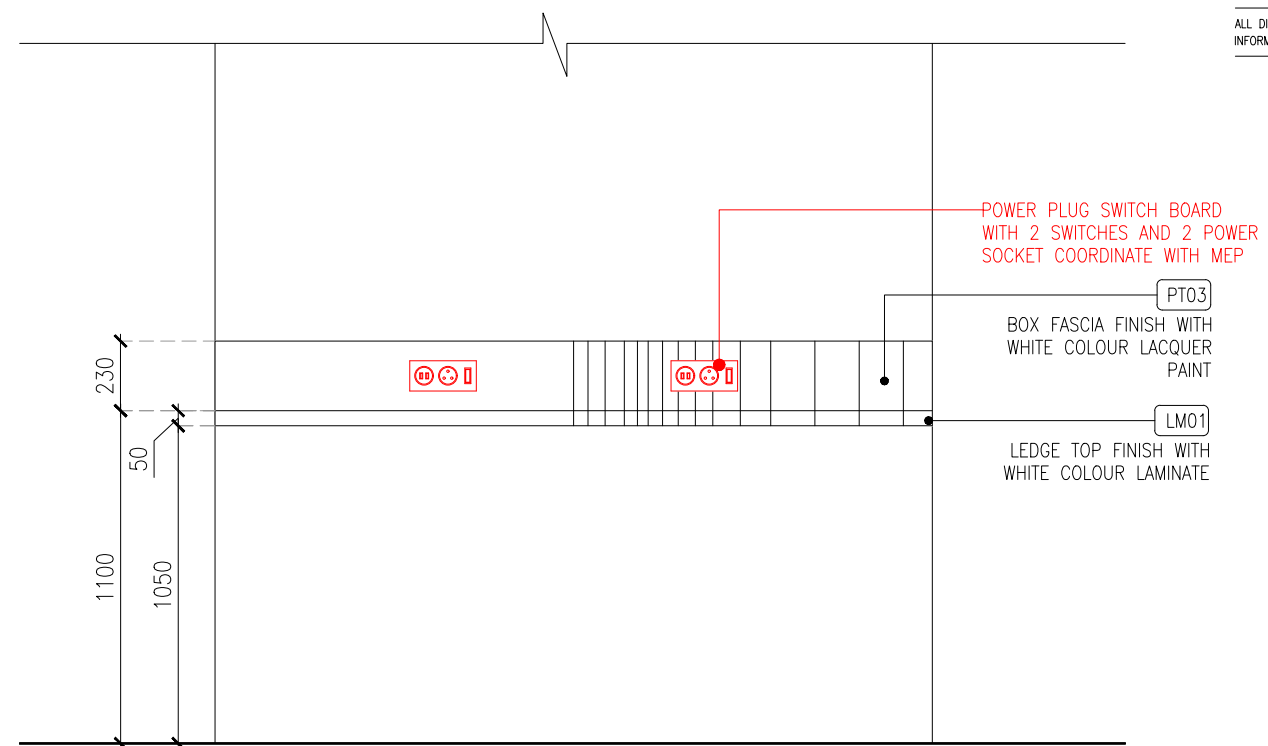

02 ELEVATION -02
04DE-410 1:25

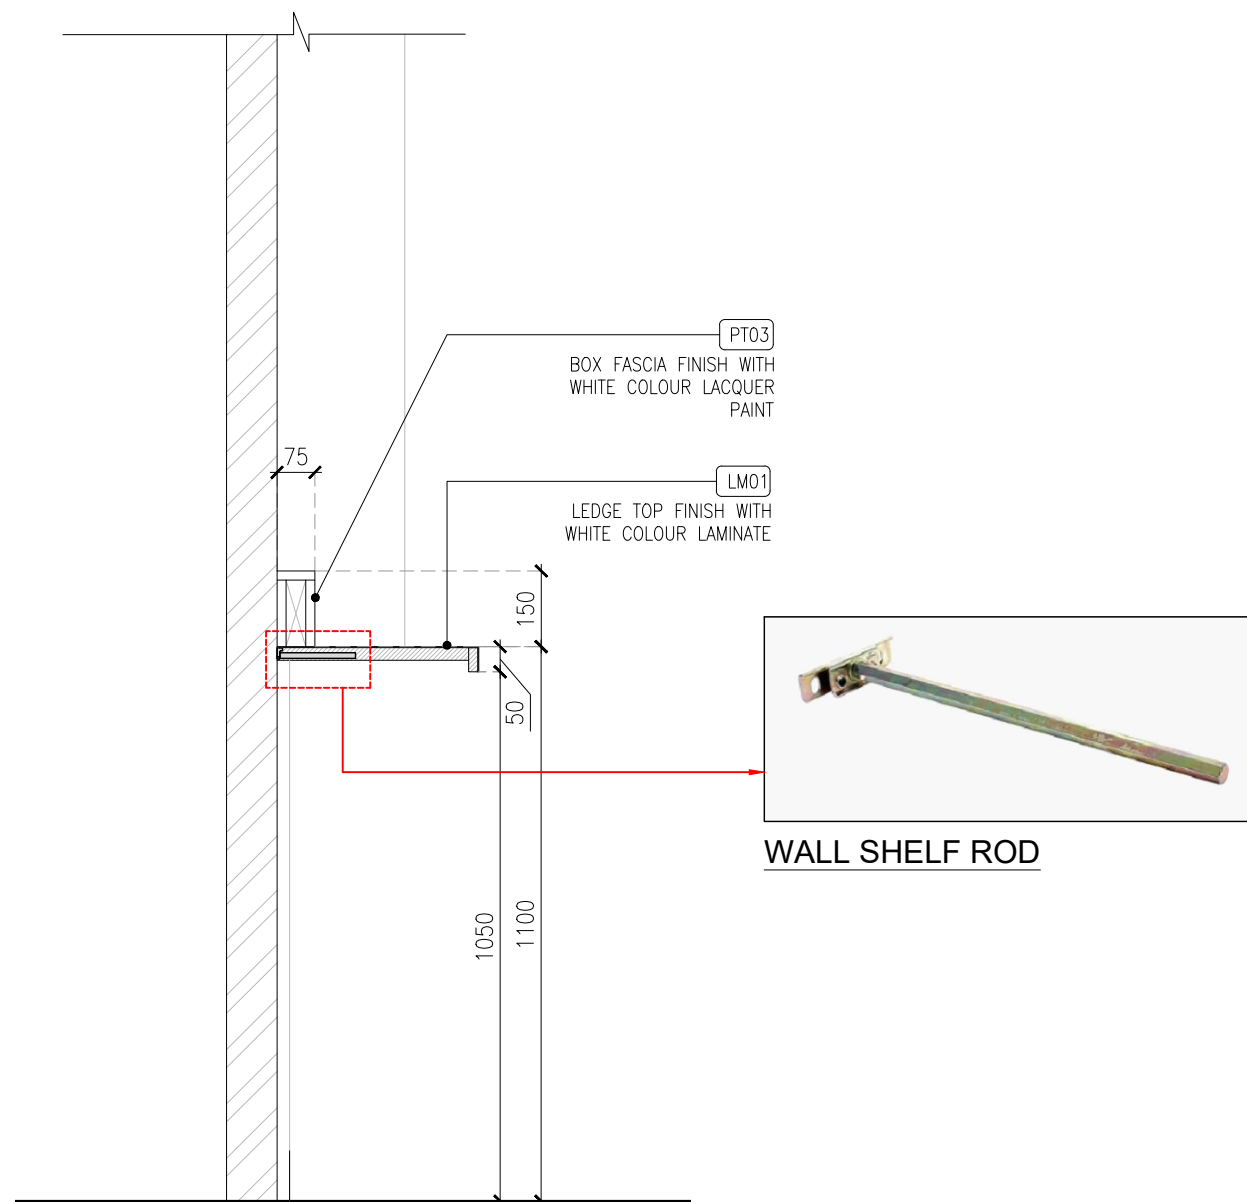

03 SECTION-01
04DE-410 1:15

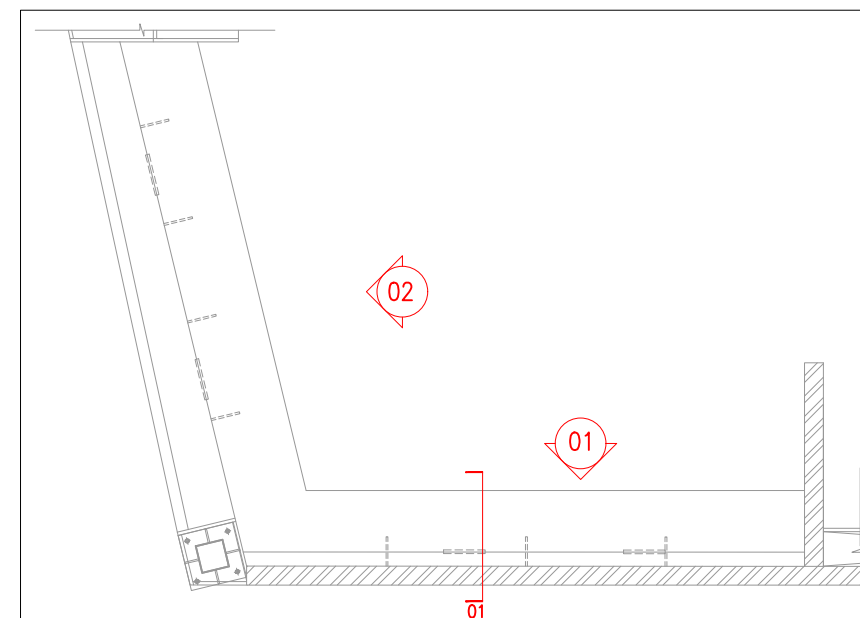

KEY PLAN

REV	DATE	DESCRIPTION	HOD	NM
C01	01.03.24	GOOD FOR CONSTRUCTION		




PROJECT
FF-025
MILIE COOKIES
HYDERABAD AIRPORT

DRAWING TITLE
J05-LEDGE DETAIL-PART:B


SCALE AS MENTIONED DATE 01.03.2024 DRAWN HOD A3 SHEET

STATUS
GOOD FOR CONSTRUCTION


ORG	PROJECT NO	DRAWING TYPE	NUMBER	REV
TFS	XXXX	04DE	410	C01

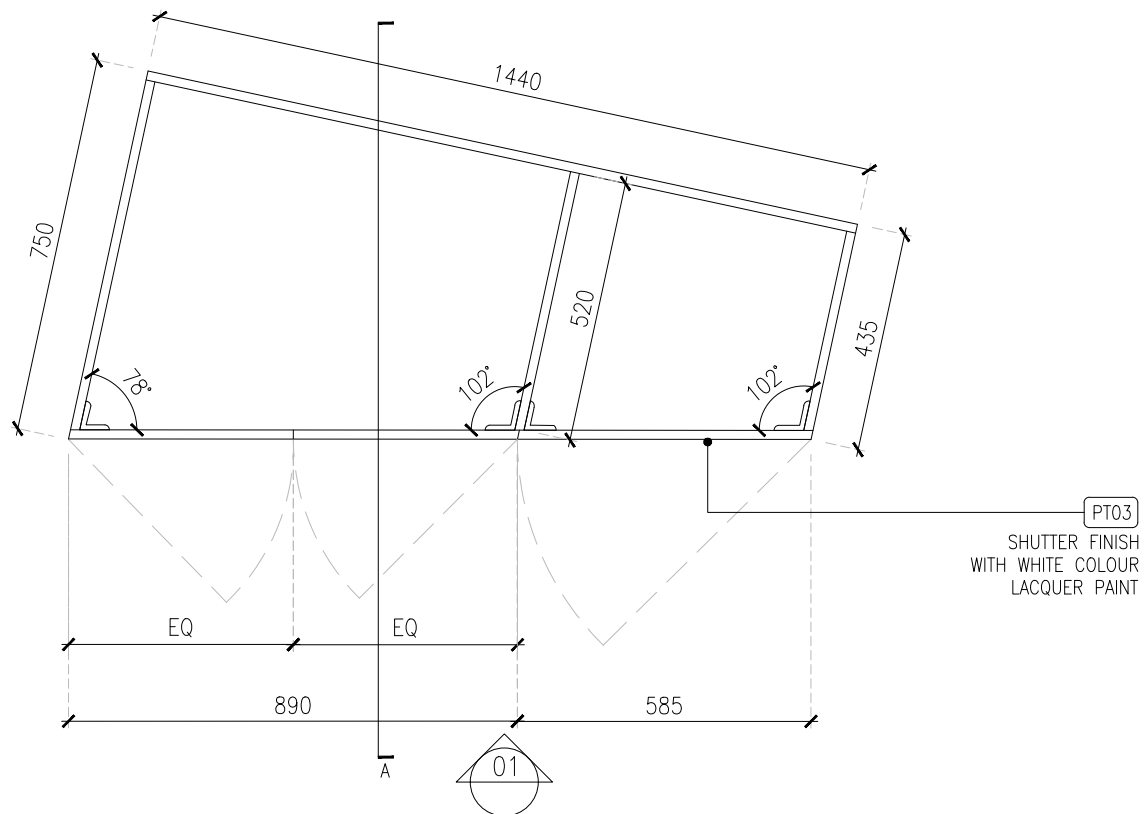

FRAMING PLAN @ 500MM LVL(SCALE 1:15)

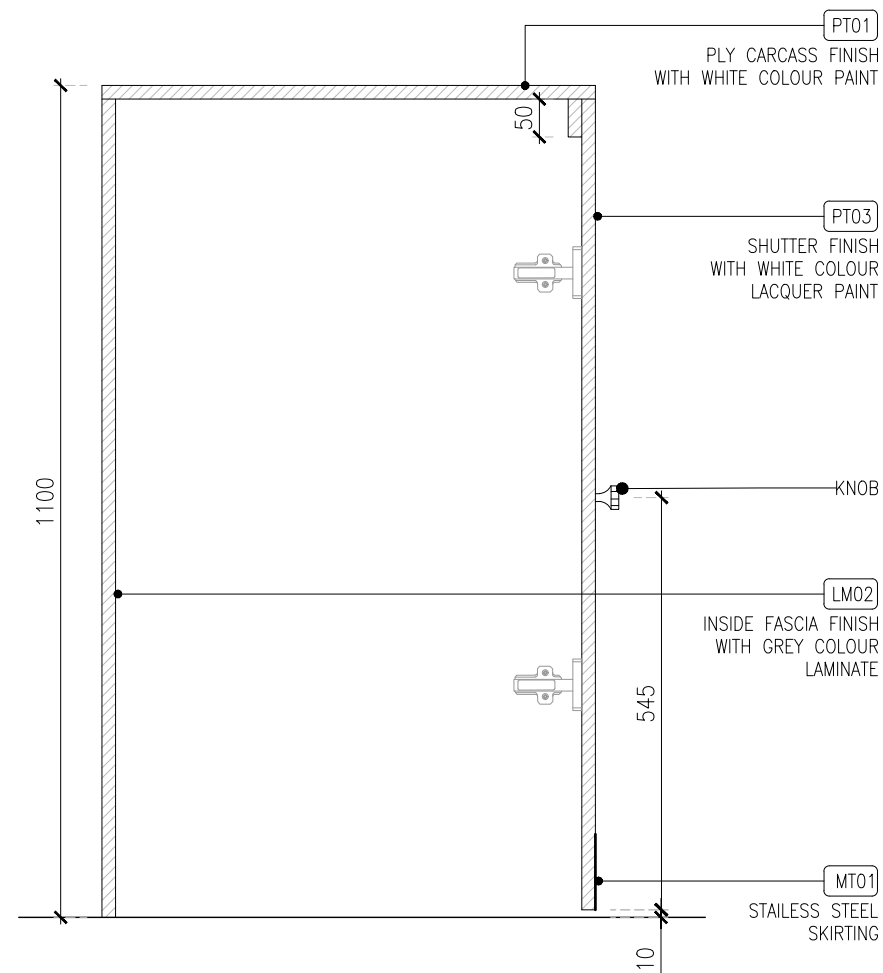


SECTION-A(SCALE 1:10)

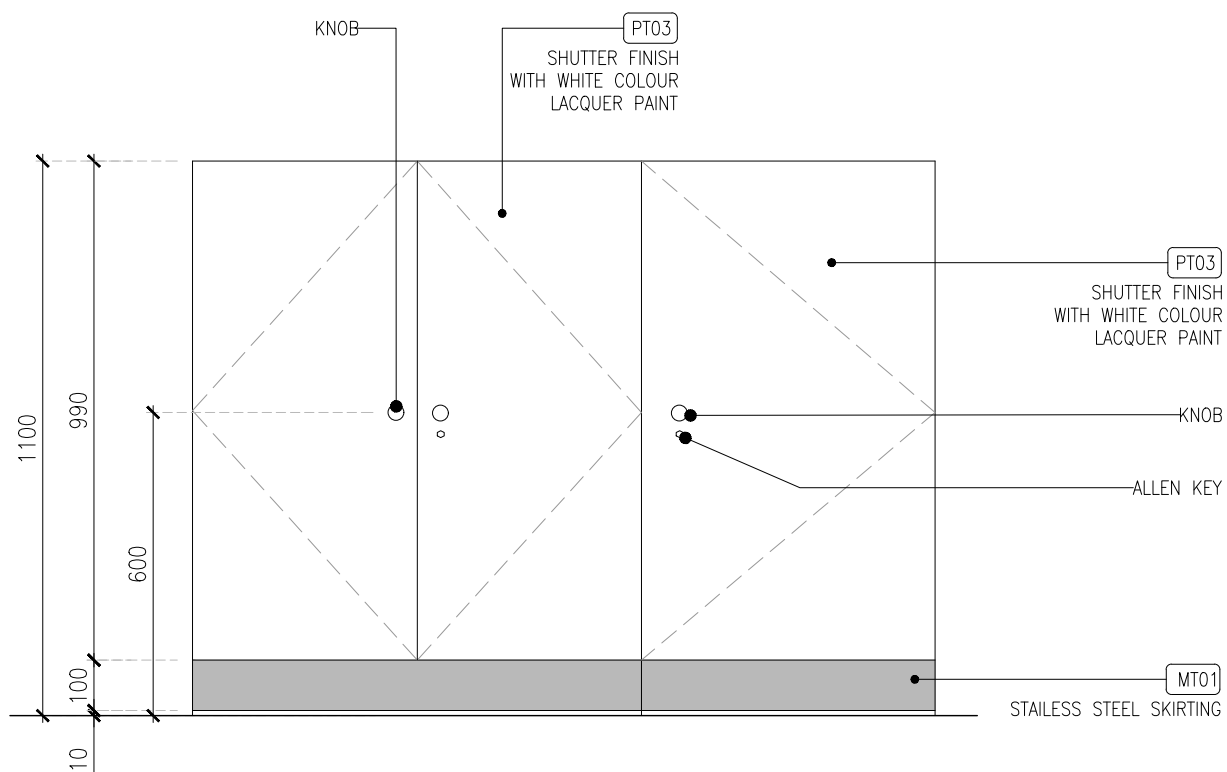

ELEVATION-01(SCALE 1:15)

01 J06 -SERVICE CLOSET DETAIL
04DE-411 1:10

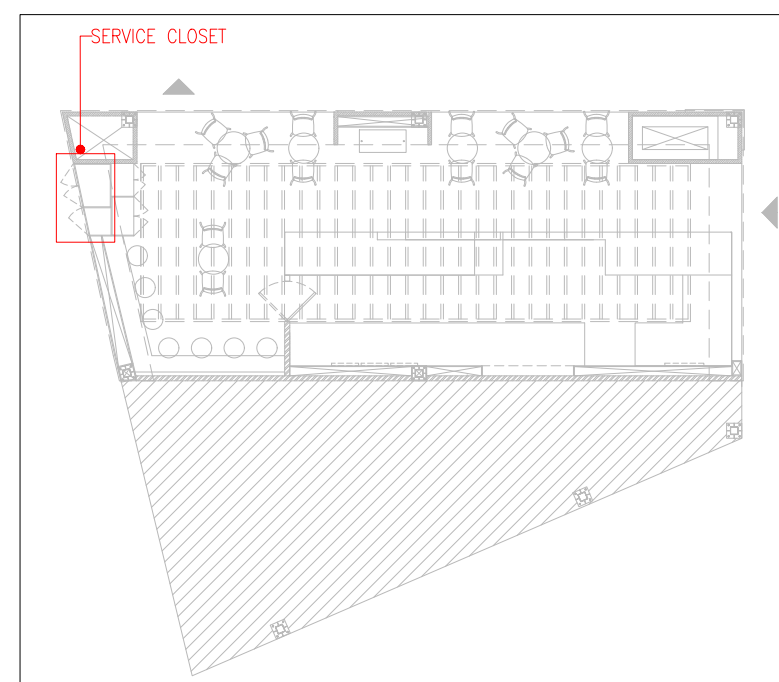

KEY PLAN

C01	01.03.24	GOOD FOR CONSTRUCTION	HOD NM
REV	DATE	DESCRIPTION	DRN CHK




PROJECT
FF-025
MILIE COOKIES
HYDERABAD AIRPORT

DRAWING TITLE
J06-SERVICE CLOSET DETAIL


SCALE AS MENTIONED DATE 01.03.2024 DRAWN HOD A3 SHEET

STATUS
GOOD FOR CONSTRUCTION

ORG	PROJECT NO	DRAWING TYPE	NUMBER	REV
TFS	XXXX	04DE	411	C01

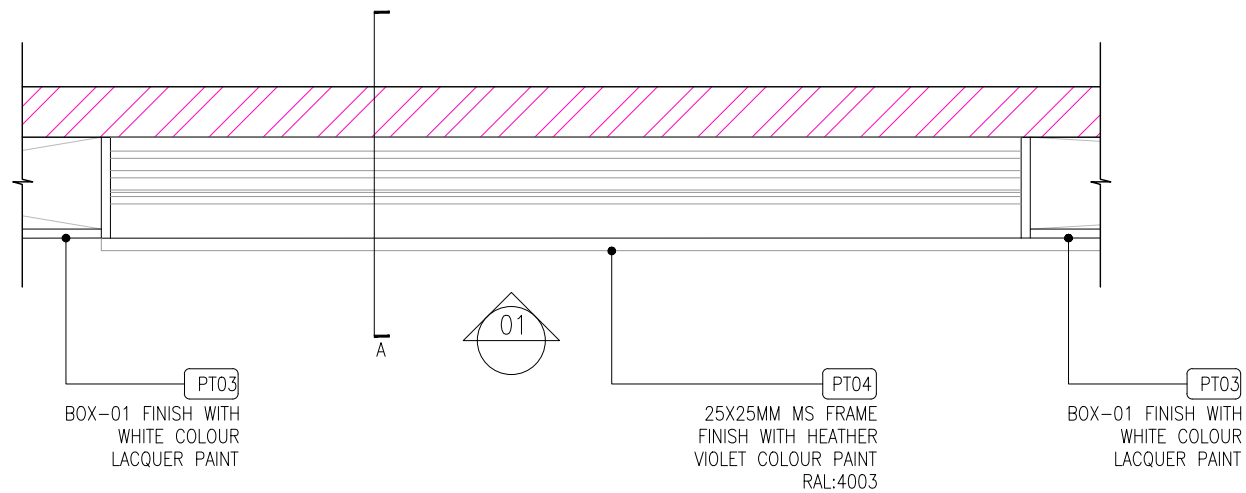


FRAMING PLAN @500MM LVL (SCALE 1:15)

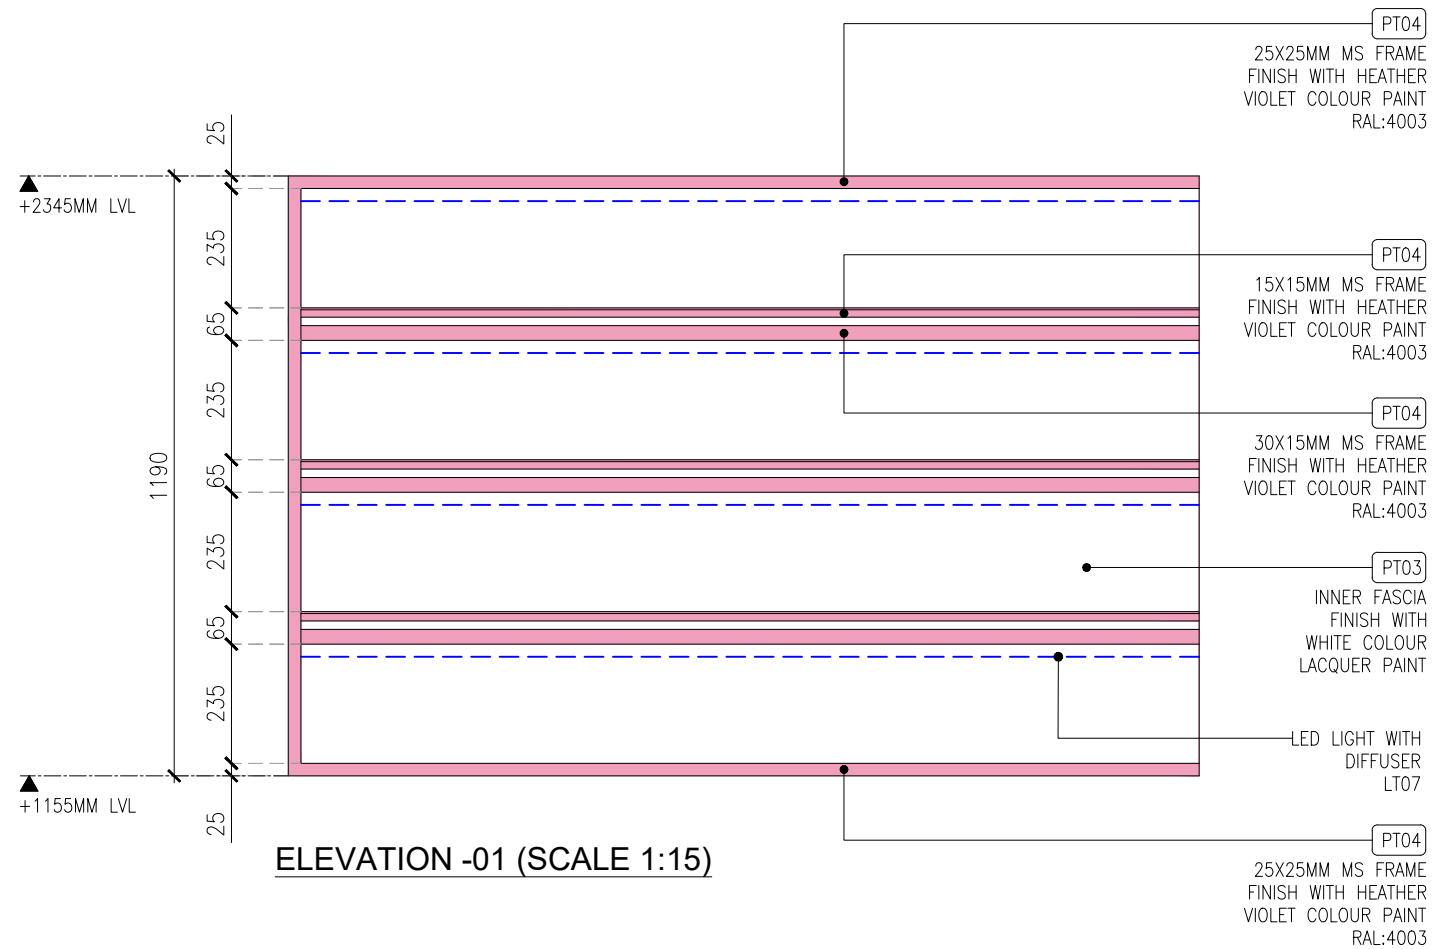


ELEVATION -01 (SCALE 1:15)

01 J07-OVERHEAD SHELF DETAIL
04DE-412 1:15

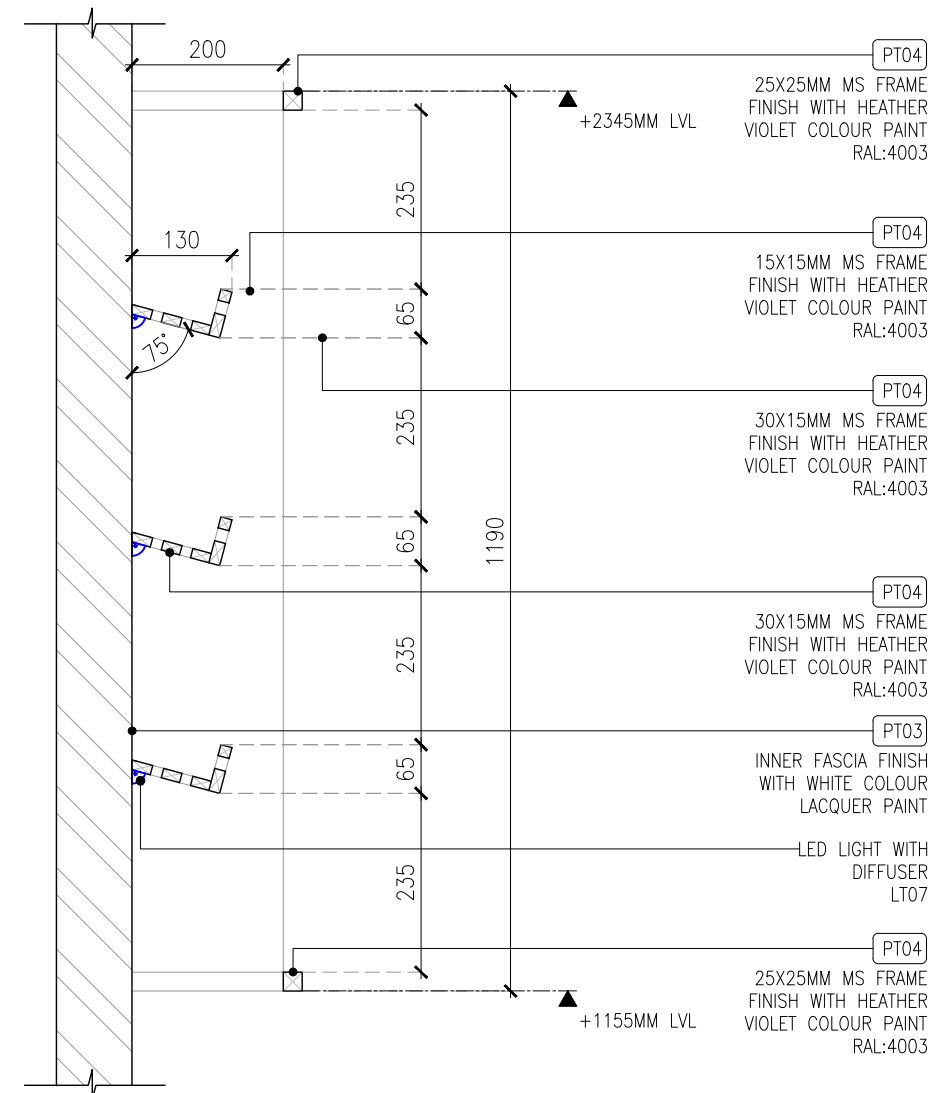

SECTION -A (SCALE 1:10)

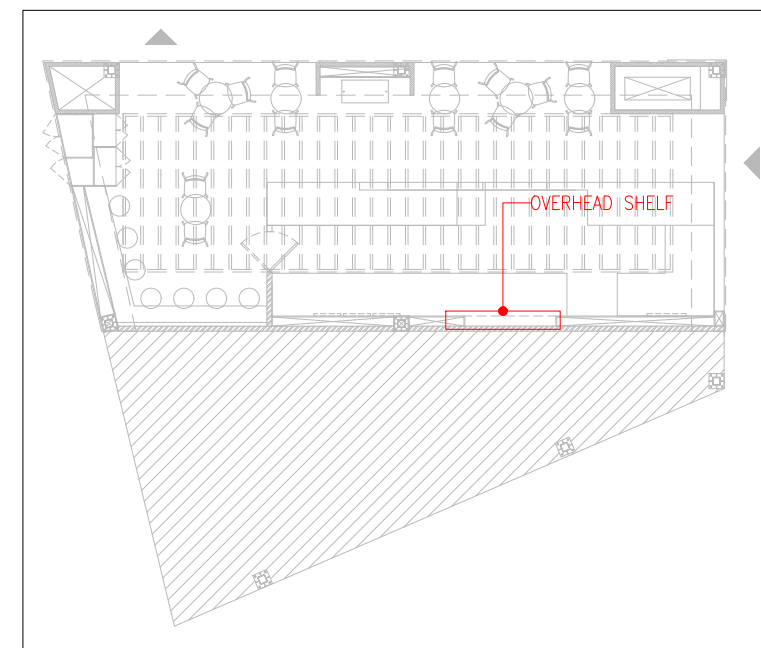

KEY PLAN

REV	DATE	DESCRIPTION	HOD	CHK
C01	01.03.24	GOOD FOR CONSTRUCTION		




PROJECT
FF-025
MILIE COOKIES
HYDERABAD AIRPORT

DRAWING TITLE
J07-OVERHEAD SHELF DETAIL


SCALE AS MENTIONED DATE 01.03.2024 DRAWN HOD A3 SHEET

STATUS
GOOD FOR CONSTRUCTION

ORG	PROJECT NO	DRAWING TYPE	NUMBER	REV
TFS	XXXX	04DE	412	C01

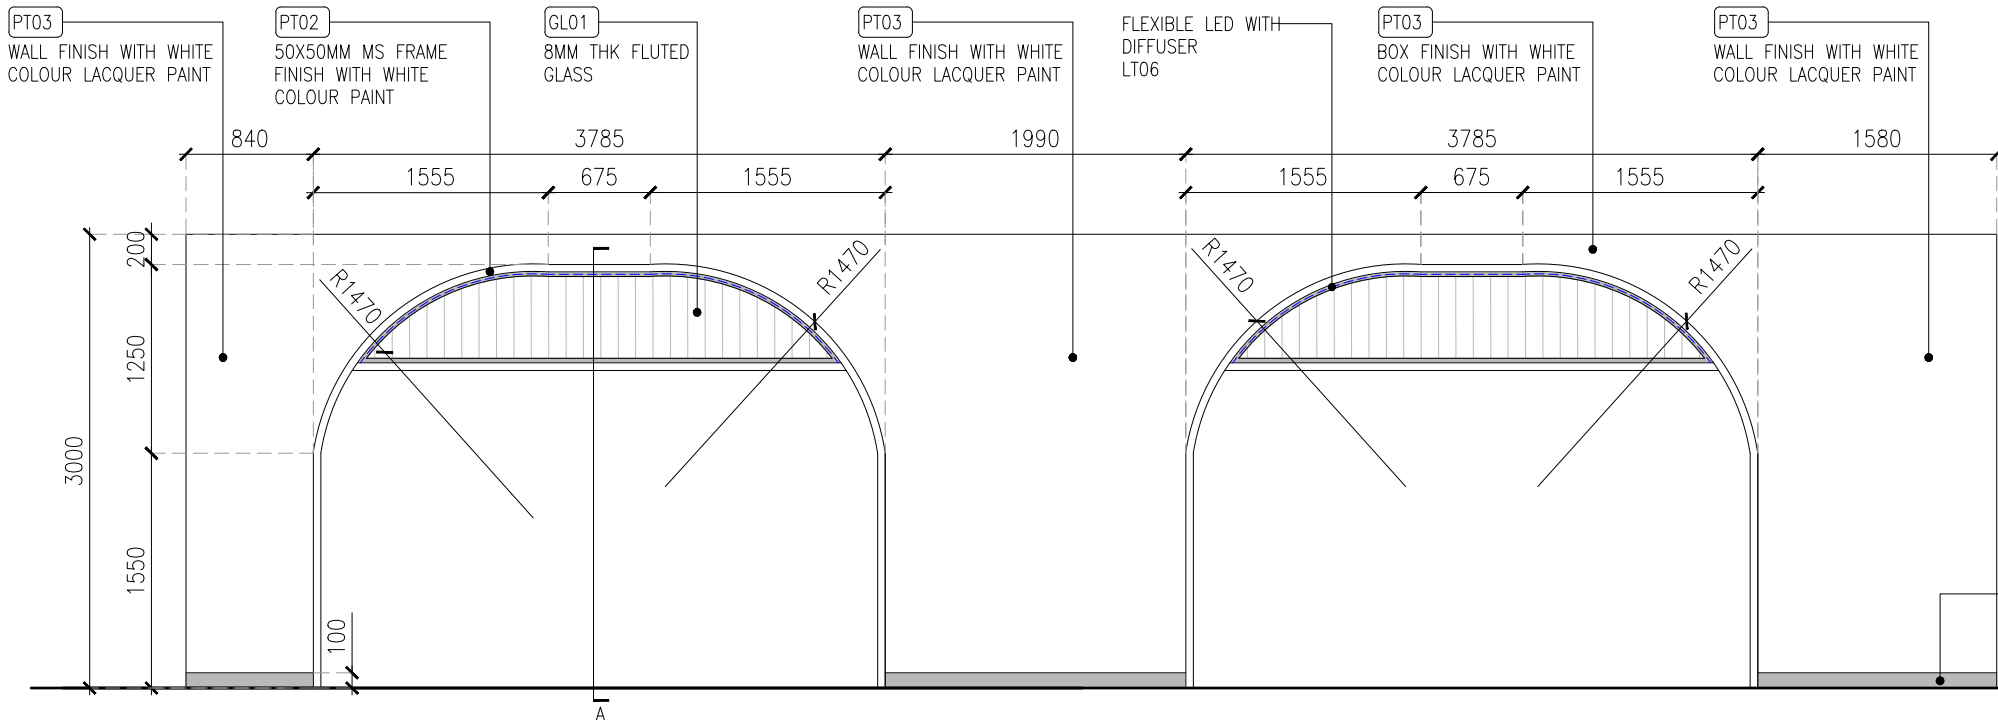


01 FACADE FRAMING (ELEVATION-02)
04DE-414 1:50

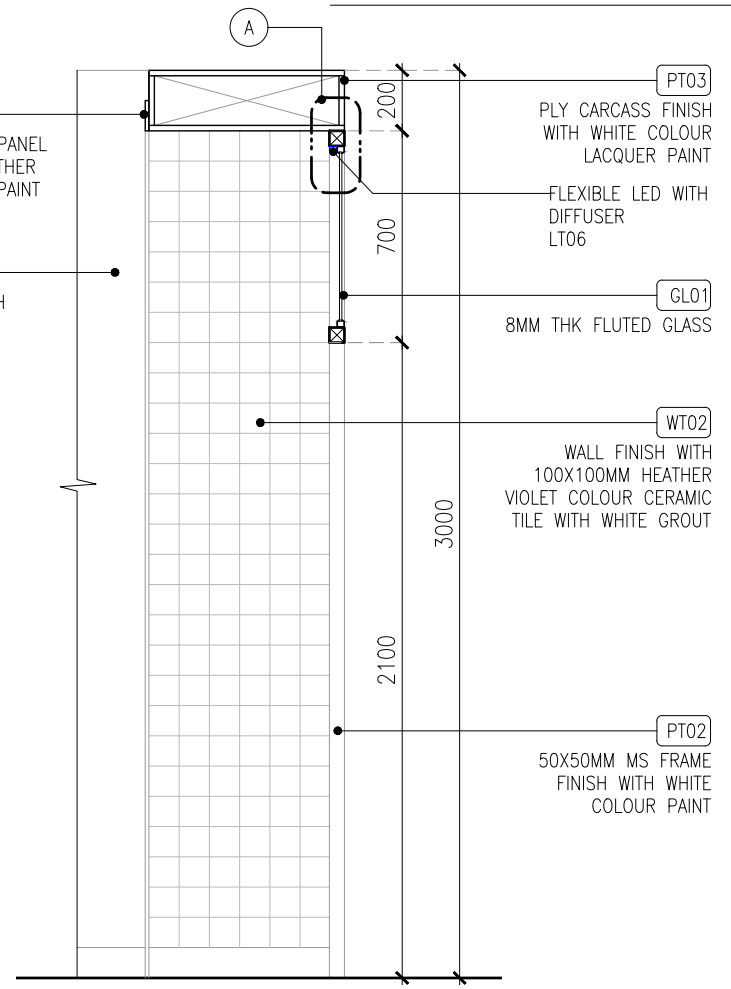


TYPICAL SECTION-A (SCALE 1:25)


ALL DIMENSIONS MUST BE CHECKED ON SITE INFORM THE ARCHITECT OF ANY DISCREPANCIES PRIOR TO CONSTRUCTION

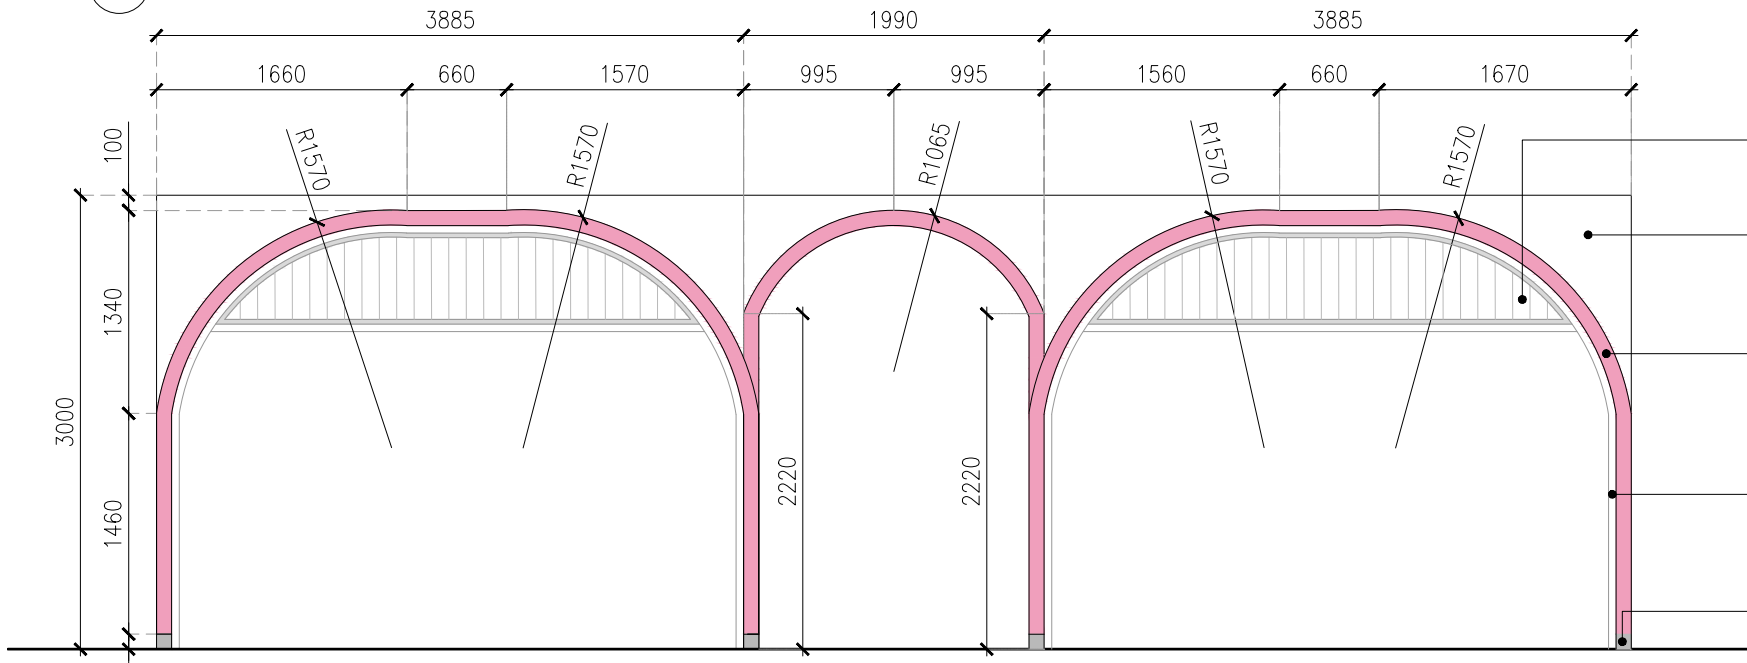

02 FACADE FRAMING (ELEVATION-03)
04DE-414 1:50

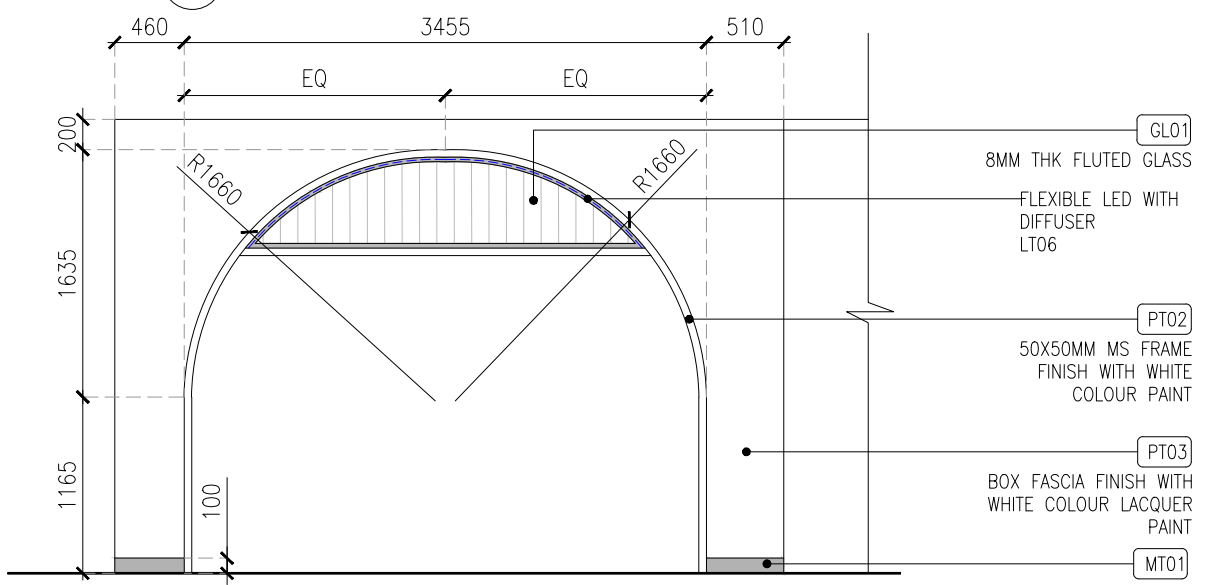

03 FACADE FRAMING (ELEVATION-01)
04DE-414 1:50

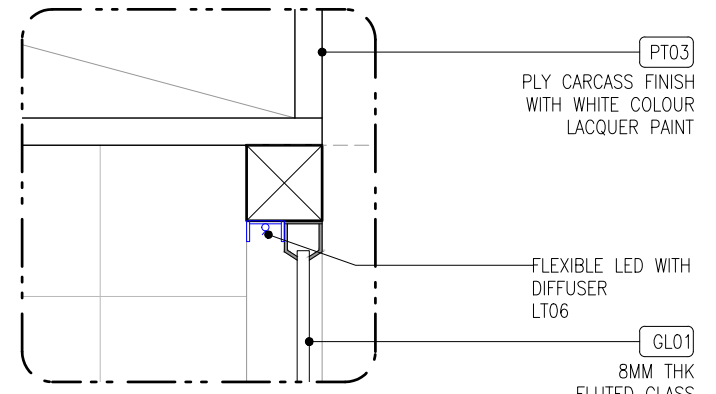

DETAIL-A(SCALE 1:5)

C01 01.03.24	GOOD FOR CONSTRUCTION	HOD NM
REV DATE	DESCRIPTION	DRN CHK



PROJECT
FF-025
MILIE COOKIES
HYDERABAD AIRPORT

DRAWING TITLE
J09-FACADE FRAMING DETAIL

SCALE 1:25 DATE 01.03.2024 DRAWN HOD A3 SHEET

STATUS
GOOD FOR CONSTRUCTION

ORG PROJECT NO DRAWING TYPE NUMBER REV
TFS XXXX 04DE 414 C01

ALL DIMENSIONS MUST BE CHECKED ON SITE
INFORM THE ARCHITECT OF ANY DISCREPANCIES PRIOR TO CONSTRUCTION




01 LIT SIGNAGE-01 (SG01)(2 Nos)
04DE-415 1:20

50MM THK FRONT LIT FRET CUT LETTERS WITH 3MM THK TURQUOISE BLUE COLOUR (RAL:5018) ACRYLIC SHEET ON FRONT & ALUMINUM SHEET ON BACK



02 LIT SIGNAGE-02 (SG02)
04DE-415 1:15


50MM THK FRONT LIT FRET CUT LETTERS WITH 3MM THK TURQUOISE BLUE COLOUR (RAL:5018) ACRYLIC SHEET ON FRONT & ALUMINUM SHEET ON BACK

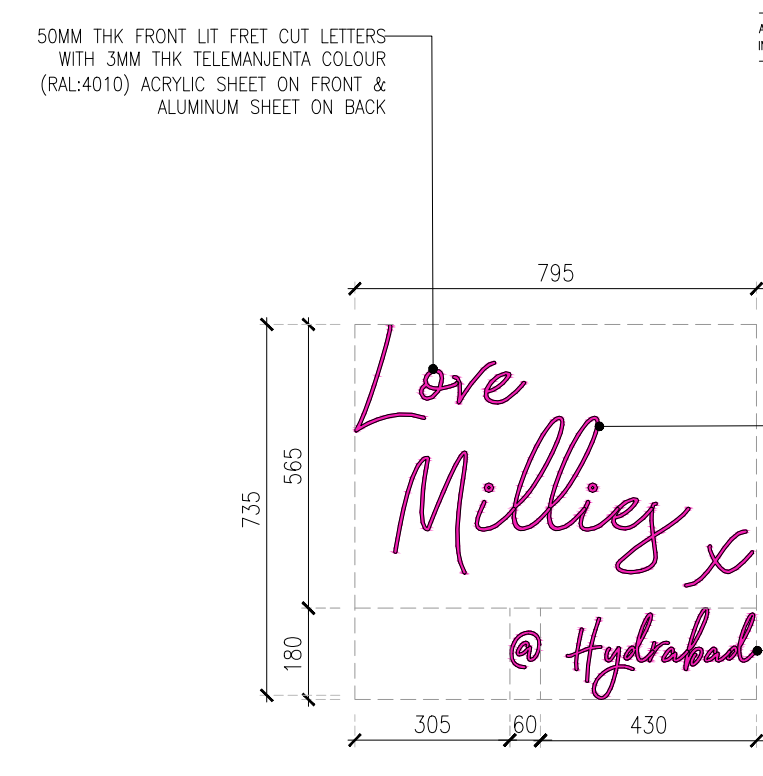

03 LIT SIGNAGE-03 (SG03)
04DE-415 1:15


50MM THK FRONT LIT FRET CUT LETTERS WITH 3MM THK TELEMANJENTA COLOUR (RAL:4010) ACRYLIC SHEET ON FRONT & ALUMINUM SHEET ON BACK

50MM THK FRONT LIT FRET CUT LETTERS WITH 3MM THK TELEMANJENTA COLOUR (RAL:4010) ACRYLIC SHEET ON FRONT & ALUMINUM SHEET ON BACK

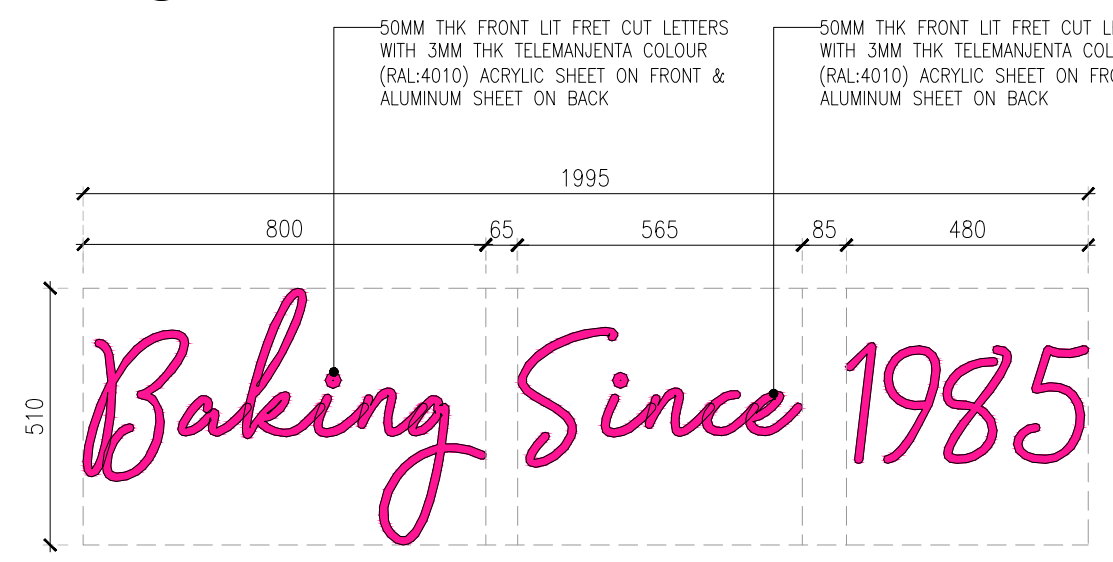


04 LIT SIGNAGE-04(SG04)
04DE-415 1:15

50MM THK FRONT LIT FRET CUT LETTERS WITH 3MM THK TELEMANJENTA COLOUR (RAL:4010) ACRYLIC SHEET ON FRONT & ALUMINUM SHEET ON BACK

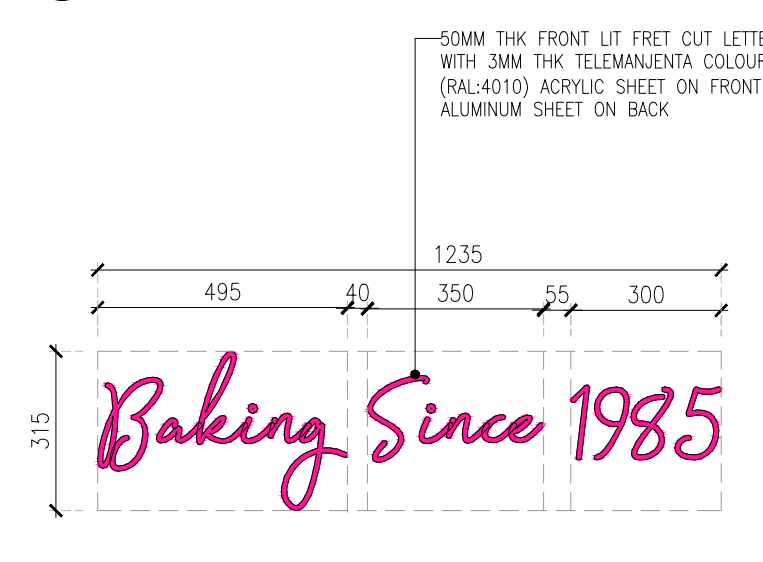

05 LIT SIGNAGE-05(SG05)
04DE-415 1:15

50MM THK FRONT LIT FRET CUT LETTERS WITH 3MM THK TELEMANJENTA COLOUR (RAL:4010) ACRYLIC SHEET ON FRONT & ALUMINUM SHEET ON BACK

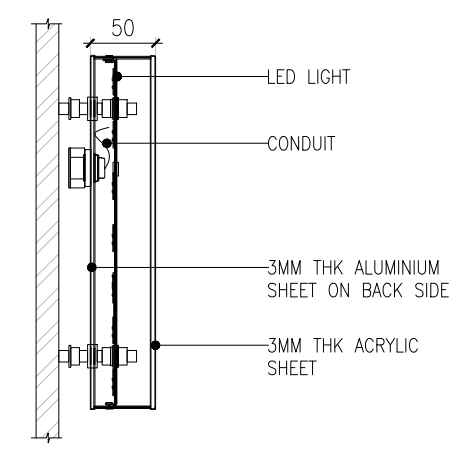

TYPICAL SECTION OF FRONT LIT SIGNAGE

C01	01.03.24	GOOD FOR CONSTRUCTION	HOD	NM
REV	DATE	DESCRIPTION	DRN	CHK



PROJECT
FF-025
MILIE COOKIES
HYDERABAD AIRPORT

DRAWING TITLE
J10-SIGNAGE DETAIL

SCALE AS MENTIONED DATE 01.03.2024 DRAWN HOD A3 SHEET

STATUS
GOOD FOR CONSTRUCTION


ORG PROJECT NO DRAWING TYPE NUMBER REV
TFS XXXX 04DE 415 C01



06 SUSPENDED LIT SIGNAGE-06(SG06)
04DE-415 1:10

PT02
10X10MM METAL FRAME
FINISH WITH WHITE
COLOUR PAINT

50MM THK FRONT LIT FRET CUT LETTERS WITH 3MM THK TELEMANJENTA COLOUR (RAL:4010) ACRYLIC SHEET ON FRONT & ALUMINUM SHEET ON BACK

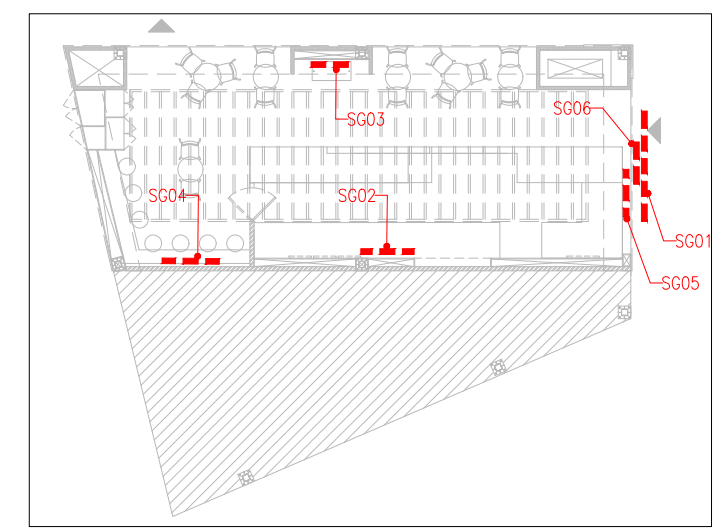

KEY PLAN