



WOW MOMO @
MUMBAI AIRPORT T-2 KIOSK.


GFC BY;
ARCH THINK STUDIO

FLAT NO-13 DDA SFS SLAT POCKET -1 SEC-6 DWARKA,
NEW DELHI-110075 EMAIL:-infoatats@gmail.com
OFF-011-35559249,MOB:9910315171



WOW MOMO @ MUMBAI AIRPORT T-2 KIOSK.

S.NO.	DRAWING NAME	DRAWING NUMBER	NO. OF DRAWINGS
A	PLAN		
1	EQUIPEMENT LAYOUT	IA-101	1
2	EQUIPMENT DIMENSIONS LAYOUT	IA-102	1
3	PARTITION DETAIL LAYOUT	IA-103	1
4	FLOORING LAYOUT	IA-104	1
5	WALL ELECTRICAL LAYOUT	IA-105	1
6	REFLECTED CEILING PLAN	IA-106	1
7	LIGHTING LAYOUT	IA-107	1
8	WALL FINISH LAYOUT	IA-108	1
10	SMOKE DETECTOR LAYOUT	IA-109	1
11	FIRE EXTINGUISHER& EVACUATION	IA-110	1
12	CCTV LAYOUT	IA-111	1
14	COORDINATED LAYOUT	IA-112	1
15	LOAD CALCULATION	IA-113	1
16	SLD (WOW MOMO)	IA-114	1
B	INTERNAL ELEVATIONS		
1	SECTIONAL DEMARCATION LAYOUT	IA-200	1
2	SECTIONAL ELEVATION AA & BB	IA-201	1
3	SECTION ELEVATION CC & COUNTER DETAIL	IA-202	1
4	FRONT ELEVATION	IA-203	1

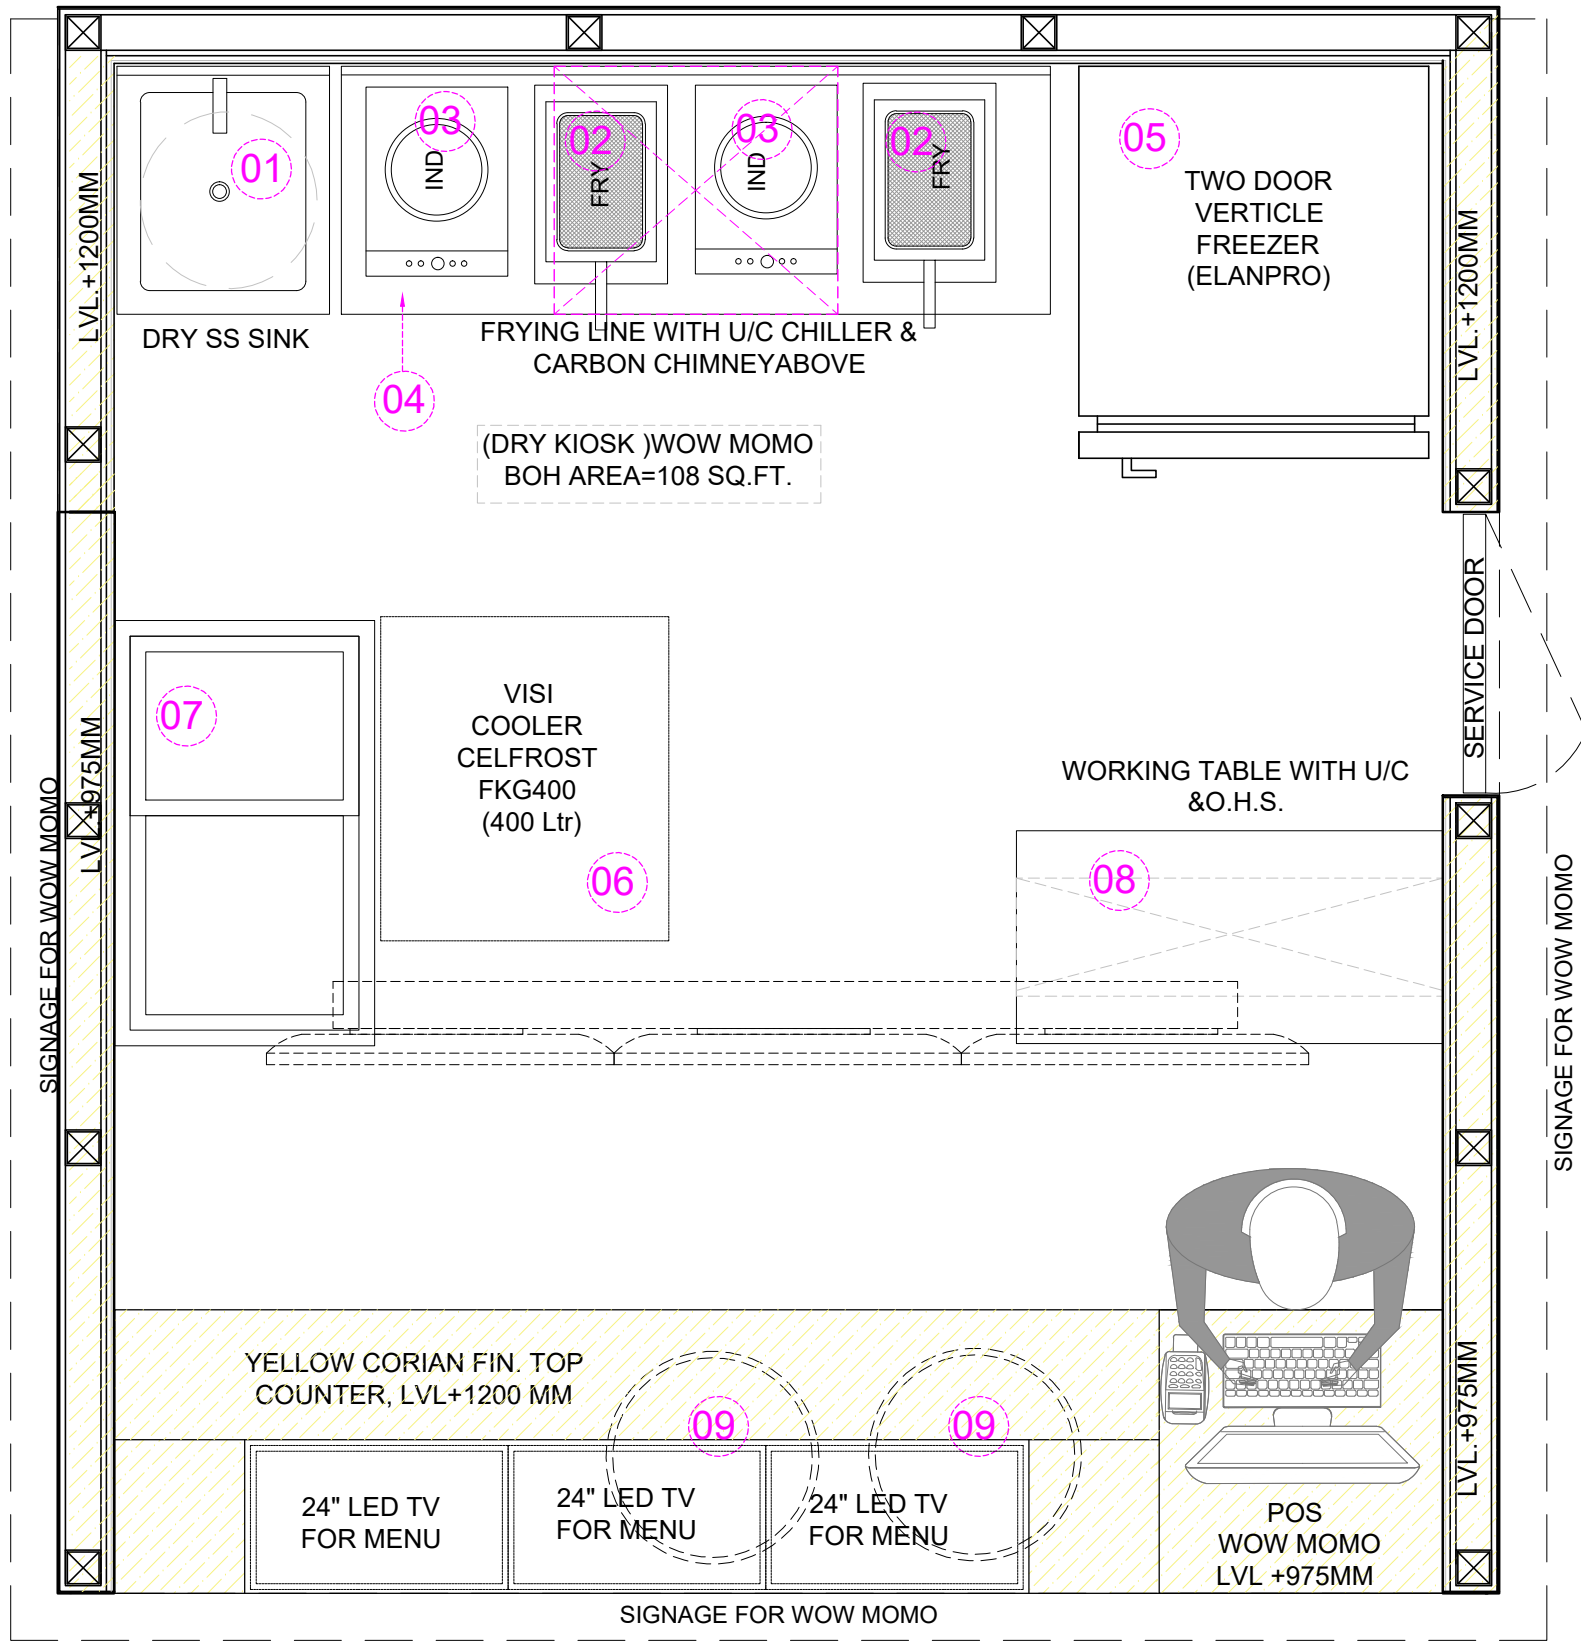

WOW MOMO & WOW CHINA EQUIPMENT LEGEND

01	SS. SINK	ONE	450 X 525 X 850	FABRICATE
02	FRYER	TWO	AS/SELECTION	
03	INDUCTION	TWO	AS/SELECTION	
04	FRYING LINE WITH U/C CHILLER WITH HOOD ABOVE	ONE	1500 X 525 X 850	FABRICATE
05	TWO DOOR REACH-IN FREEZER	ONE	740 X 830X1950	ELANPRO
06	VISI COOLER F KG 400 (400 LTR.) (MAKE : CELFROST)	ONE	610 X 686 X 1981	CELFROST
07	CF 210, CHEST FREEZER 210 LTR. (MAKE: CELFROST)	ONE	900 X 550 X 835	CELFROST
08	WORKING TABLE WITH U/C & O.H.S	ONE	900 X 450 X 835	FABRICATE
09	VEG & NON VEG STEAMER	TWO	AS/SELECTION	

NOTE : WALL MOUNTED SHELF AS/SITE REQUIREMENT R/O AND GEYSER WILL BE PLACED ABOVE SINK

EQUIPMENT LAYOUT

PROJECT
WOW MOMO @ MUMBAI AIRPORT T-2.

CLIENT
WOW! MOMO FOODS PVT. LTD.

CONSULTANT

ARCHITECT / INTERIOR DESIGN

ARCHITECTURE & INTERIOR DESIGN
FLAT NO-13 DDA SFS SLAT POCKET -1 SEC-6 DWARKA, NEW DELHI-110075
EMAIL:-infoatats@gmail.com
OFF-011-35559249, MOB:9910315171

TITLE

EQUIPMENT LAYOUT

NOTE:
THIS DRAWING & DESIGN IS THE COPYRIGHT OF THE DESIGNER. NO PORTION MAY BE REPRODUCED WITHOUT THE WRITTEN PERMISSION OF THE DESIGNERS

- ALL DIMENSIONS ARE INCLUDING FINISHES
- DO NOT SCALE DRAWING. ONLY MENTIONED DIMENSIONS ARE TO BE CONSIDERED.
- ALL DIMENSIONS MUST BE CHECKED BEFORE COMMENCING WORK ON SITE.
- ANY DISCREPANCIES SHALL BE BROUGHT UNDER THE NOTICE OF ARCHITECTS PRIOR COMMENCEMENT OF WORK.

REVISION


S.NO.	REMARKS	DATE
1	REV 1	00/00/00
2	REV 2	00/00/00
3	REV 3	00/00/00
4	REV 4	00/00/00
5	REV 5	00/00/00
6	REV 6	00/00/00
7	REV 7	00/00/00
8	REV 8	00/00/00

CONSULTANT

RELEASE FOR

INFORMATION | TENDER | CONSTRUCTION | AS BUILT

DATE	05-10-2024
SCALE	NTS
DRAWN BY	PUSHPENDER
CHECKED BY	AR.MANISH
PRINTED BY	-
DWG. NO.	IA-101

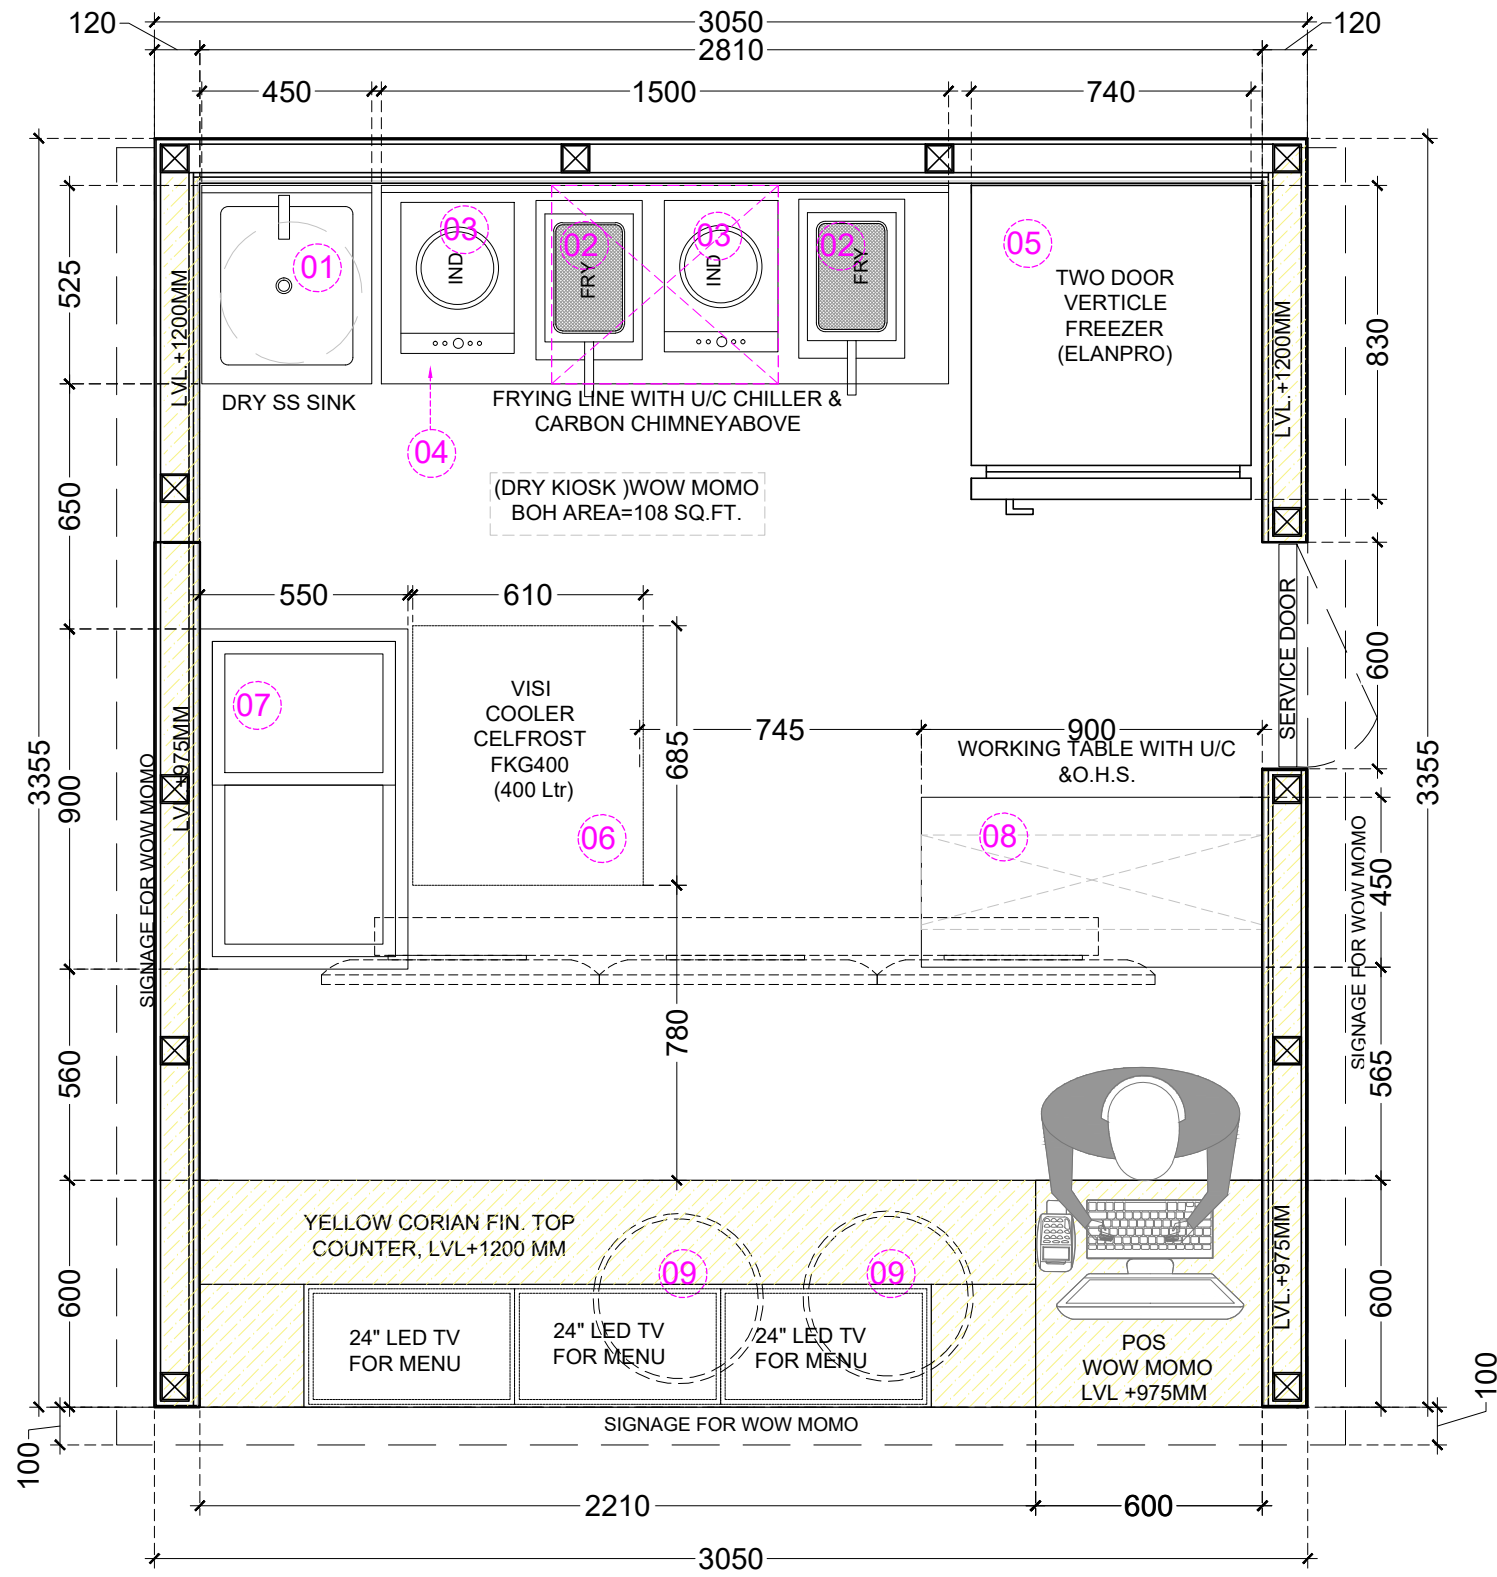

EQUIPMENT DIM. LAYOUT

WOW MOMO & WOW CHINA EQUIPMENT LEGEND

01	SS. SINK	ONE	450 X 525 X 850	FABRICATE
02	FRYER	TWO	AS/SELECTION	
03	INDUCTION	TWO	AS/SELECTION	
04	FRYING LINE WITH U/C CHILLER WITH HOOD ABOVE	ONE	1500 X 525 X 850	FABRICATE
05	TWO DOOR REACH-IN FREEZER	ONE	740 X 830X1950	ELANPRO
06	VISI COOLER F KG 400 (400 LTR.) (MAKE : CELFROST)	ONE	610 X 686 X 1981	CELFROST
07	CF 210, CHEST FREEZER 210 LTR. (MAKE: CELFROST)	ONE	900 X 550 X 835	CELFROST
08	WORKING TABLE WITH U/C & O.H.S	ONE	900 X 450 X 835	FABRICATE
09	VEG & NON VEG STEAMER	TWO	AS/SELECTION	

NOTE : WALL MOUNTED SHELF AS/SITE REQUIREMENT R/O AND GEYSER WILL BE PLACED ABOVE SINK

PROJECT
WOW MOMO @ MUMBAI AIRPORT T-2.

CLIENT
WOW! MOMO FOODS PVT. LTD.

CONSULTANT

ARCHITECT / INTERIOR DESIGN

ARCHITECTURE STUDIO
FLAT NO-13 DDA SFS SLAT POCKET -1 SEC-6 DWARKA, NEW DELHI-110075
EMAIL:-infoatats@gmail.com
OFF-011-35559249, MOB:9910315171

TITLE
EQUIPMENT DIMENSION LAYOUT

NOTE:
THIS DRAWING & DESIGN IS THE COPYRIGHT OF THE DESIGNER. NO PORTION MAY BE REPRODUCED WITHOUT THE WRITTEN PERMISSION OF THE DESIGNERS

- ALL DIMENSIONS ARE INCLUDING FINISHES
- DO NOT SCALE DRAWING. ONLY MENTIONED DIMENSIONS ARE TO BE CONSIDERED.
- ALL DIMENSIONS MUST BE CHECKED BEFORE COMMENCING WORK ON SITE.
- ANY DISCREPANCIES SHALL BE BROUGHT UNDER THE NOTICE OF ARCHITECTS PRIOR COMMENCEMENT OF WORK.

REVISION



S.NO.	REMARKS	DATE
1	REV 1	00/00/00
2	REV 2	00/00/00
3	REV 3	00/00/00
4	REV 4	00/00/00
5	REV 5	00/00/00
6	REV 6	00/00/00
7	REV 7	00/00/00
8	REV 8	00/00/00

CONSULTANT

RELEASE FOR

INFORMATION | TENDER | CONSTRUCTION | AS BUILT

DATE	05-10-2024
SCALE	NTS
DRAWN BY	PUSHPENDER
CHECKED BY	AR.MANISH
PRINTED BY	-
DWG. NO.	IA-102

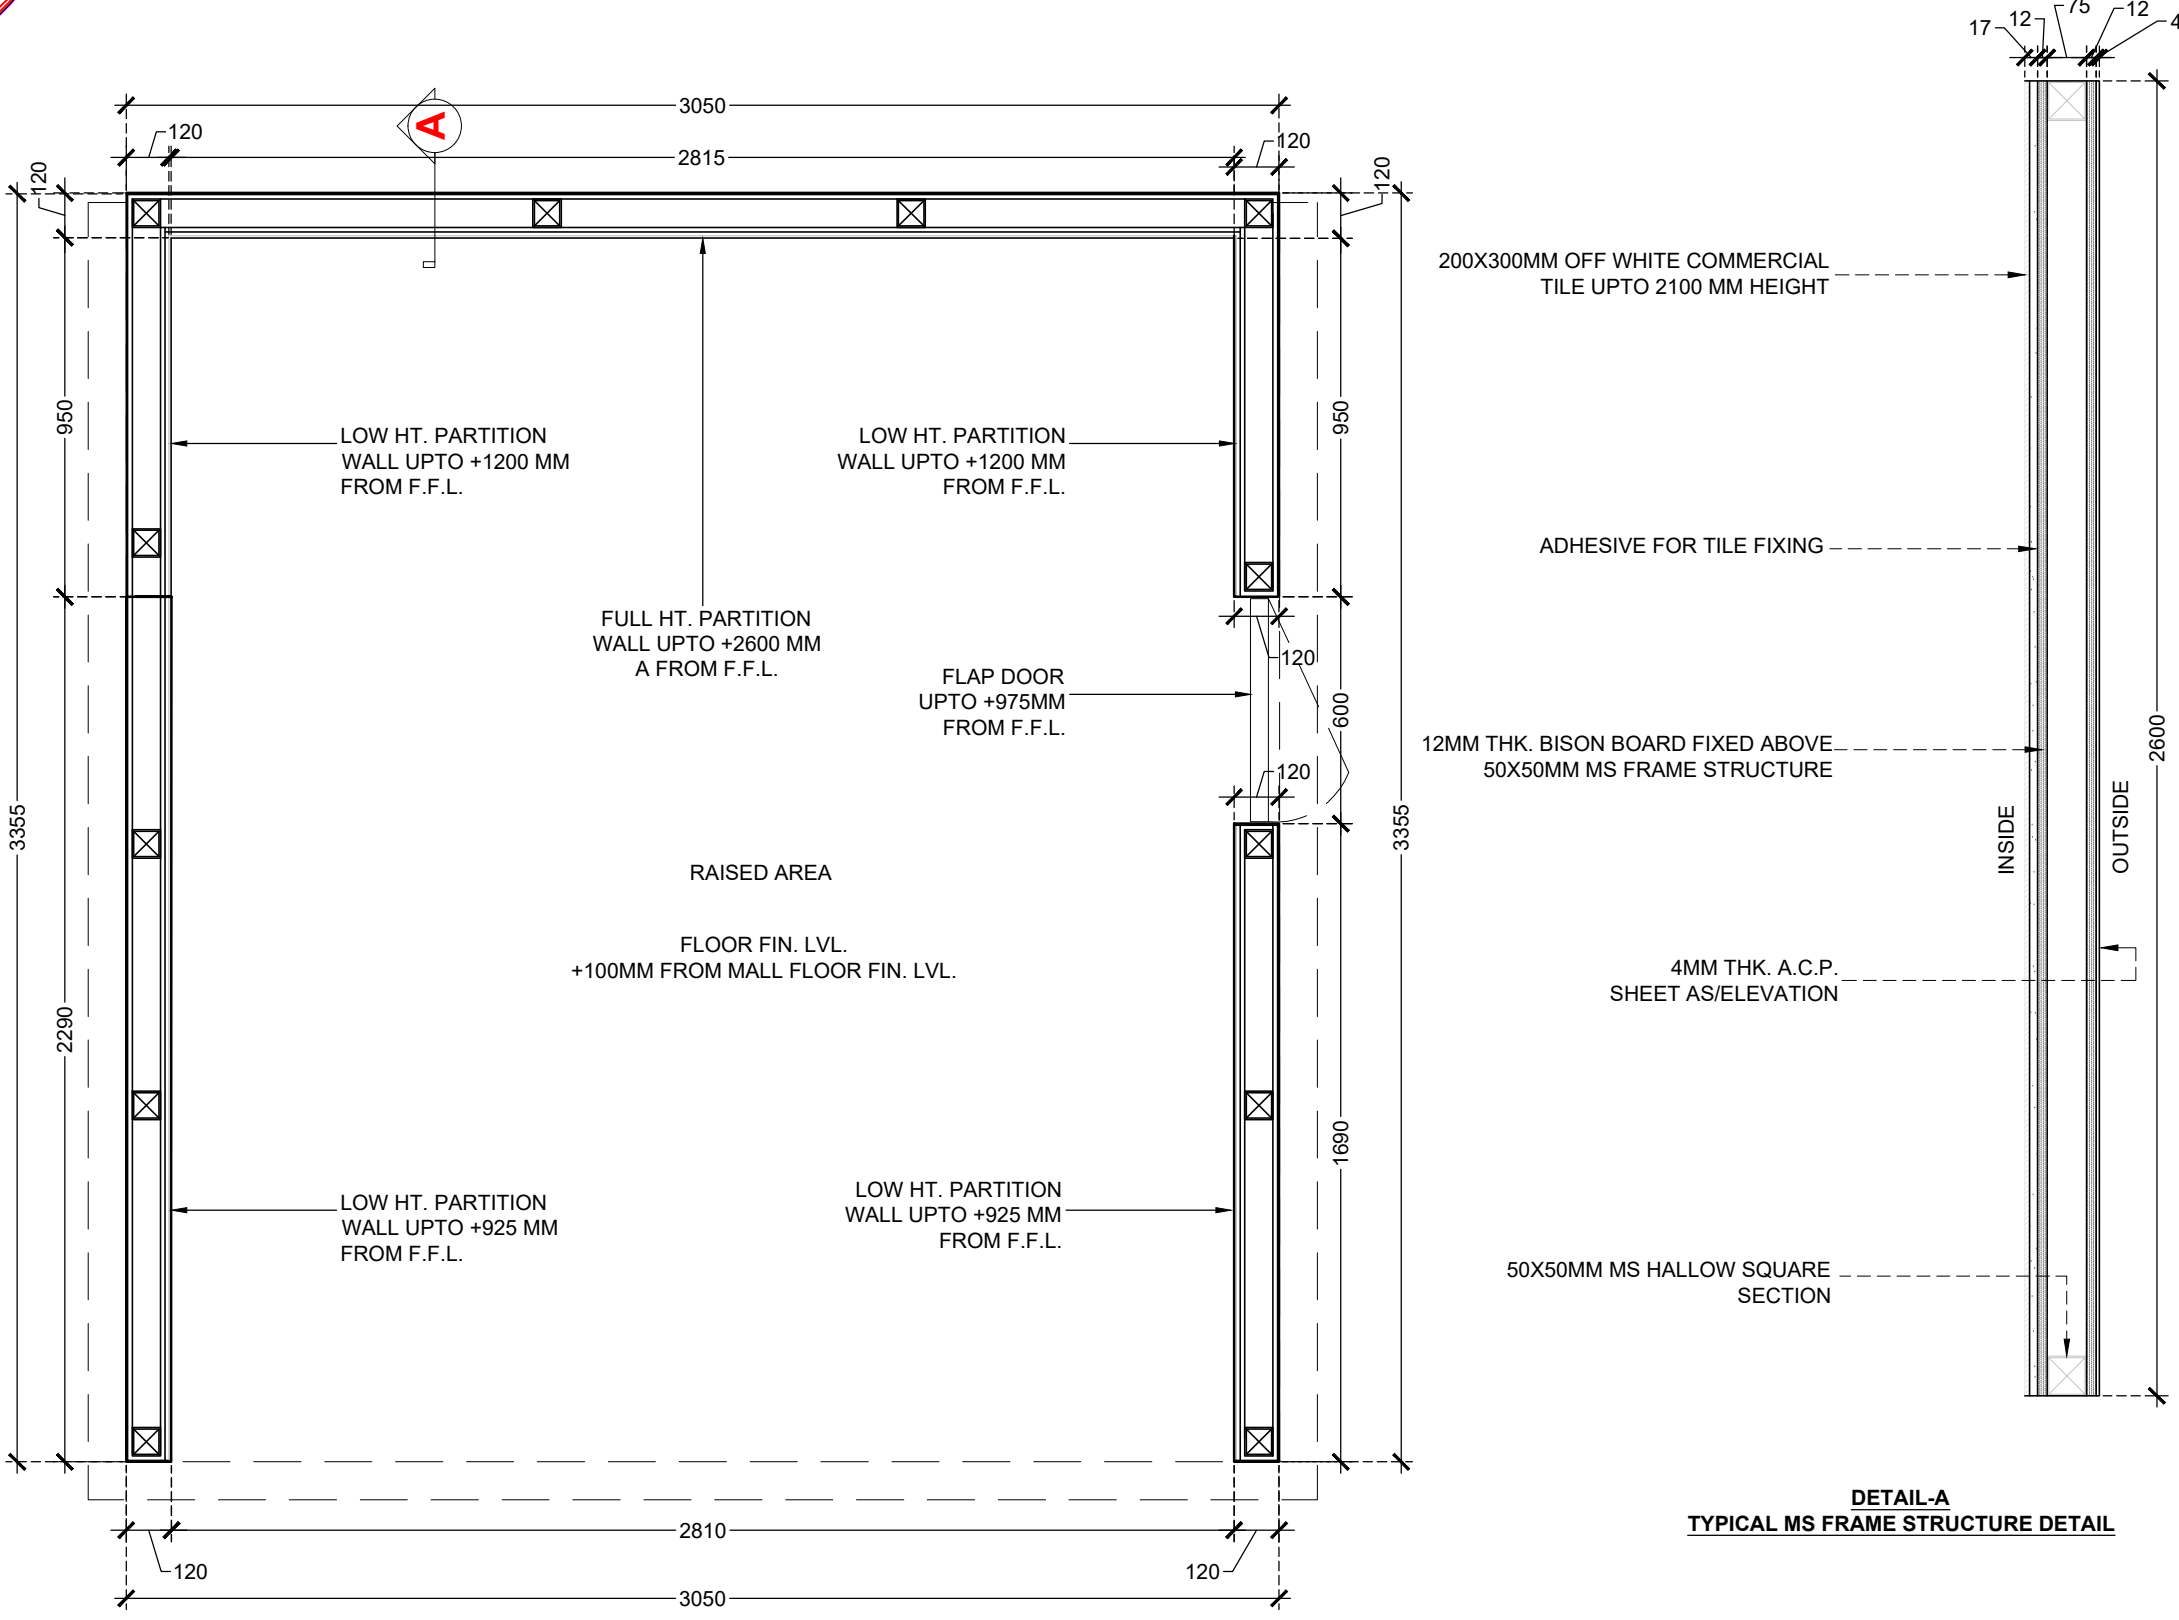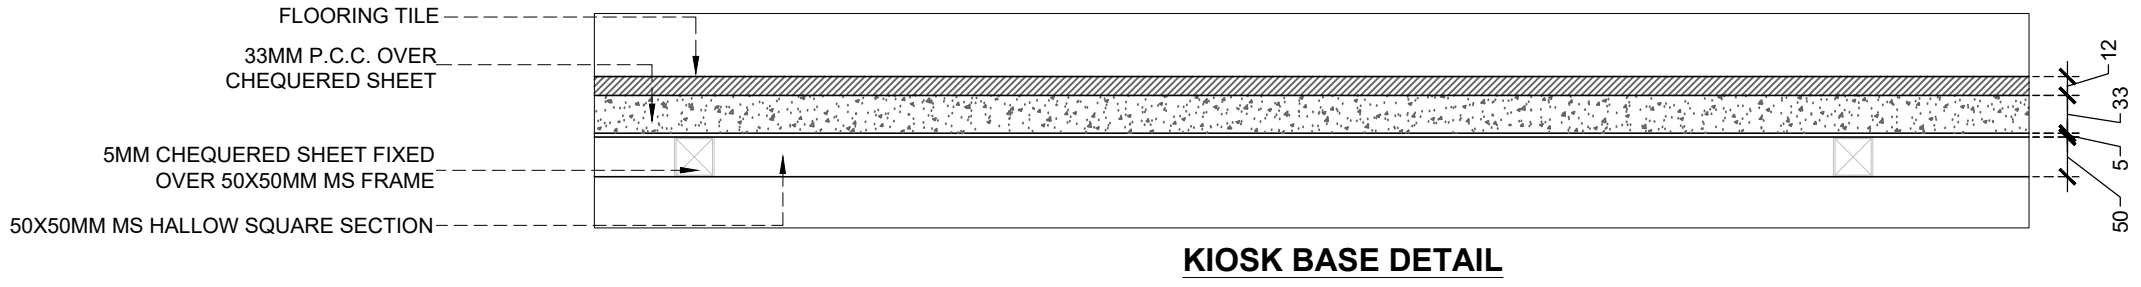

PARTITION WALL LAYOUT

PROJECT
WOW MOMO @ MUMBAI AIRPORT T-2.

CLIENT
WOW! MOMO FOODS PVT. LTD.

CONSULTANT
-

ARCHITECT / INTERIOR DESIGN

 FLAT NO-13 DDA SFS
 SLAT POCKET -1 SEC-6
 DWARKA,
 NEW DELHI-110075
 EMAIL:-infoatats@gmail.com
 OFF-011-35559249,
 MOB:9910315171

TITLE
PARTITION WALL LAYOUT

NOTE:
THIS DRAWING & DESIGN IS THE COPYRIGHT OF THE DESIGNER. NO PORTION MAY BE REPRODUCED WITHOUT THE WRITTEN PERMISSION OF THE DESIGNERS


1. ALL DIMENSIONS ARE INCLUDING FINISHES
2. DO NOT SCALE DRAWING. ONLY MENTIONED DIMENSIONS ARE TO BE CONSIDERED.
3. ALL DIMENSIONS MUST BE CHECKED BEFORE COMMENCING WORK ON SITE.
4. ANY DISCREPANCIES SHALL BE BROUGHT UNDER THE NOTICE OF ARCHITECTS PRIOR COMMENCEMENT OF WORK.

S.NO.	REMARKS	DATE
1	REV 1	00/00/00
2	REV 2	00/00/00
3	REV 3	00/00/00
4	REV 4	00/00/00
5	REV 5	00/00/00
6	REV 6	00/00/00
7	REV 7	00/00/00
8	REV 8	00/00/00

CONSULTANT
-


RELEASE FOR			
INFORMATION	TENDER	CONSTRUCTION	AS BUILT



DATE	05-10-2024
SCALE	NTS
DRAWN BY	PUSHPENDER
CHECKED BY	AR.MANISH
PRINTED BY	-
DWG. NO.	IA-103

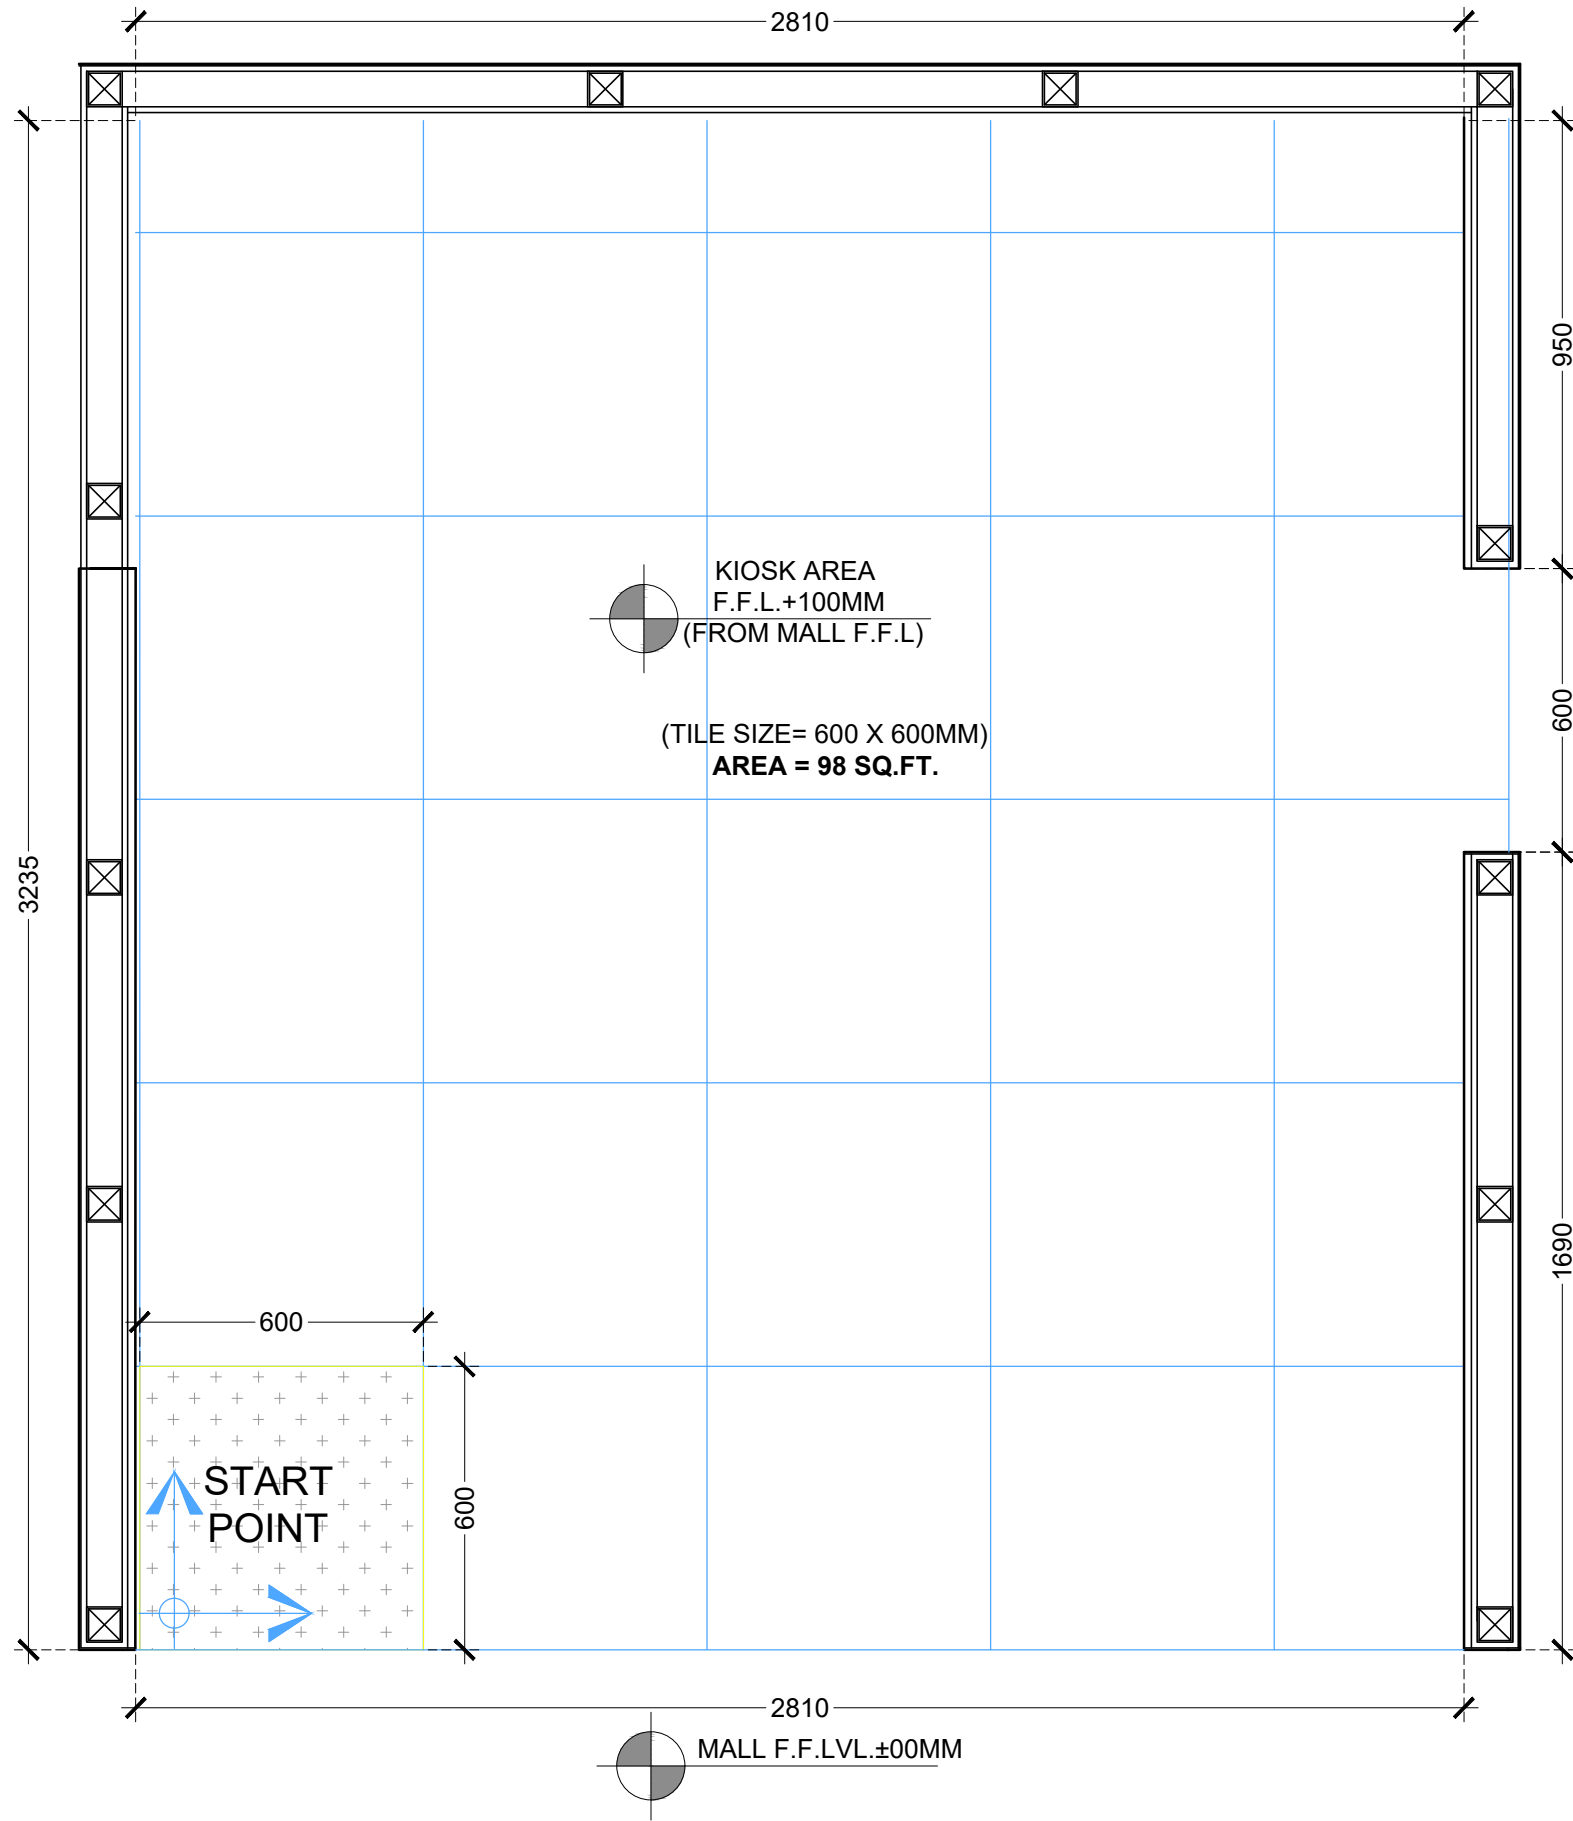

FLOORING LEGEND	
LEGEND	DESCRIPTION
	GREY TILE (600X600) (APPROX 98 SQ. FT. AREA)

FLOORING LAYOUT

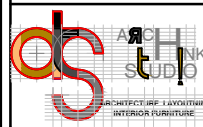PROJECT WOW MOMO @ MUMBAI AIRPORT T-2.		CLIENT WOW! MOMO FOODS PVT. LTD.		CONSULTANT -		ARCHITECT / INTERIOR DESIGN  FLAT NO-13 DDA SFS SLAT POCKET -1 SEC-6 DWARKA, NEW DELHI-110075 EMAIL:-infoatats@gmail.com OFF-011-35559249, MOB:9910315171		TITLE FLOORING LAYOUT																																								
NOTE: THIS DRAWING & DESIGN IS THE COPYRIGHT OF THE DESIGNER. NO PORTION MAY BE REPRODUCED WITHOUT THE WRITTEN PERMISSION OF THE DESIGNERS 1. ALL DIMENSIONS ARE INCLUDING FINISHES 2. DO NOT SCALE DRAWING. ONLY MENTIONED DIMENSIONS ARE TO BE CONSIDERED. 3. ALL DIMENSIONS MUST BE CHECKED BEFORE COMMENCING WORK ON SITE. 4. ANY DISCREPANCIES SHALL BE BROUGHT UNDER THE NOTICE OF ARCHITECTS PRIOR COMMENCEMENT OF WORK.		REVISION <table border="1"> <thead> <tr> <th>S.NO.</th> <th>REMARKS</th> <th>DATE</th> </tr> </thead> <tbody> <tr><td>1</td><td>REV 1</td><td>00/00/00</td></tr> <tr><td>2</td><td>REV 2</td><td>00/00/00</td></tr> <tr><td>3</td><td>REV 3</td><td>00/00/00</td></tr> <tr><td>4</td><td>REV 4</td><td>00/00/00</td></tr> <tr><td>5</td><td>REV 5</td><td>00/00/00</td></tr> <tr><td>6</td><td>REV 6</td><td>00/00/00</td></tr> <tr><td>7</td><td>REV 7</td><td>00/00/00</td></tr> <tr><td>8</td><td>REV 8</td><td>00/00/00</td></tr> </tbody> </table>		S.NO.	REMARKS	DATE	1	REV 1	00/00/00	2	REV 2	00/00/00	3	REV 3	00/00/00	4	REV 4	00/00/00	5	REV 5	00/00/00	6	REV 6	00/00/00	7	REV 7	00/00/00	8	REV 8	00/00/00	CONSULTANT -		RELEASE FOR INFORMATION TENDER CONSTRUCTION AS BUILT		<table border="1"> <tr> <td>DATE</td> <td>05-10-2024</td> </tr> <tr> <td>SCALE</td> <td>NTS</td> </tr> <tr> <td>DRAWN BY</td> <td>PUSHPENDER</td> </tr> <tr> <td>CHECKED BY</td> <td>AR.MANISH</td> </tr> <tr> <td>PRINTED BY</td> <td>-</td> </tr> <tr> <td>DWG. NO.</td> <td>IA-104</td> </tr> </table>		DATE	05-10-2024	SCALE	NTS	DRAWN BY	PUSHPENDER	CHECKED BY	AR.MANISH	PRINTED BY	-	DWG. NO.	IA-104
S.NO.	REMARKS	DATE																																														
1	REV 1	00/00/00																																														
2	REV 2	00/00/00																																														
3	REV 3	00/00/00																																														
4	REV 4	00/00/00																																														
5	REV 5	00/00/00																																														
6	REV 6	00/00/00																																														
7	REV 7	00/00/00																																														
8	REV 8	00/00/00																																														
DATE	05-10-2024																																															
SCALE	NTS																																															
DRAWN BY	PUSHPENDER																																															
CHECKED BY	AR.MANISH																																															
PRINTED BY	-																																															
DWG. NO.	IA-104																																															

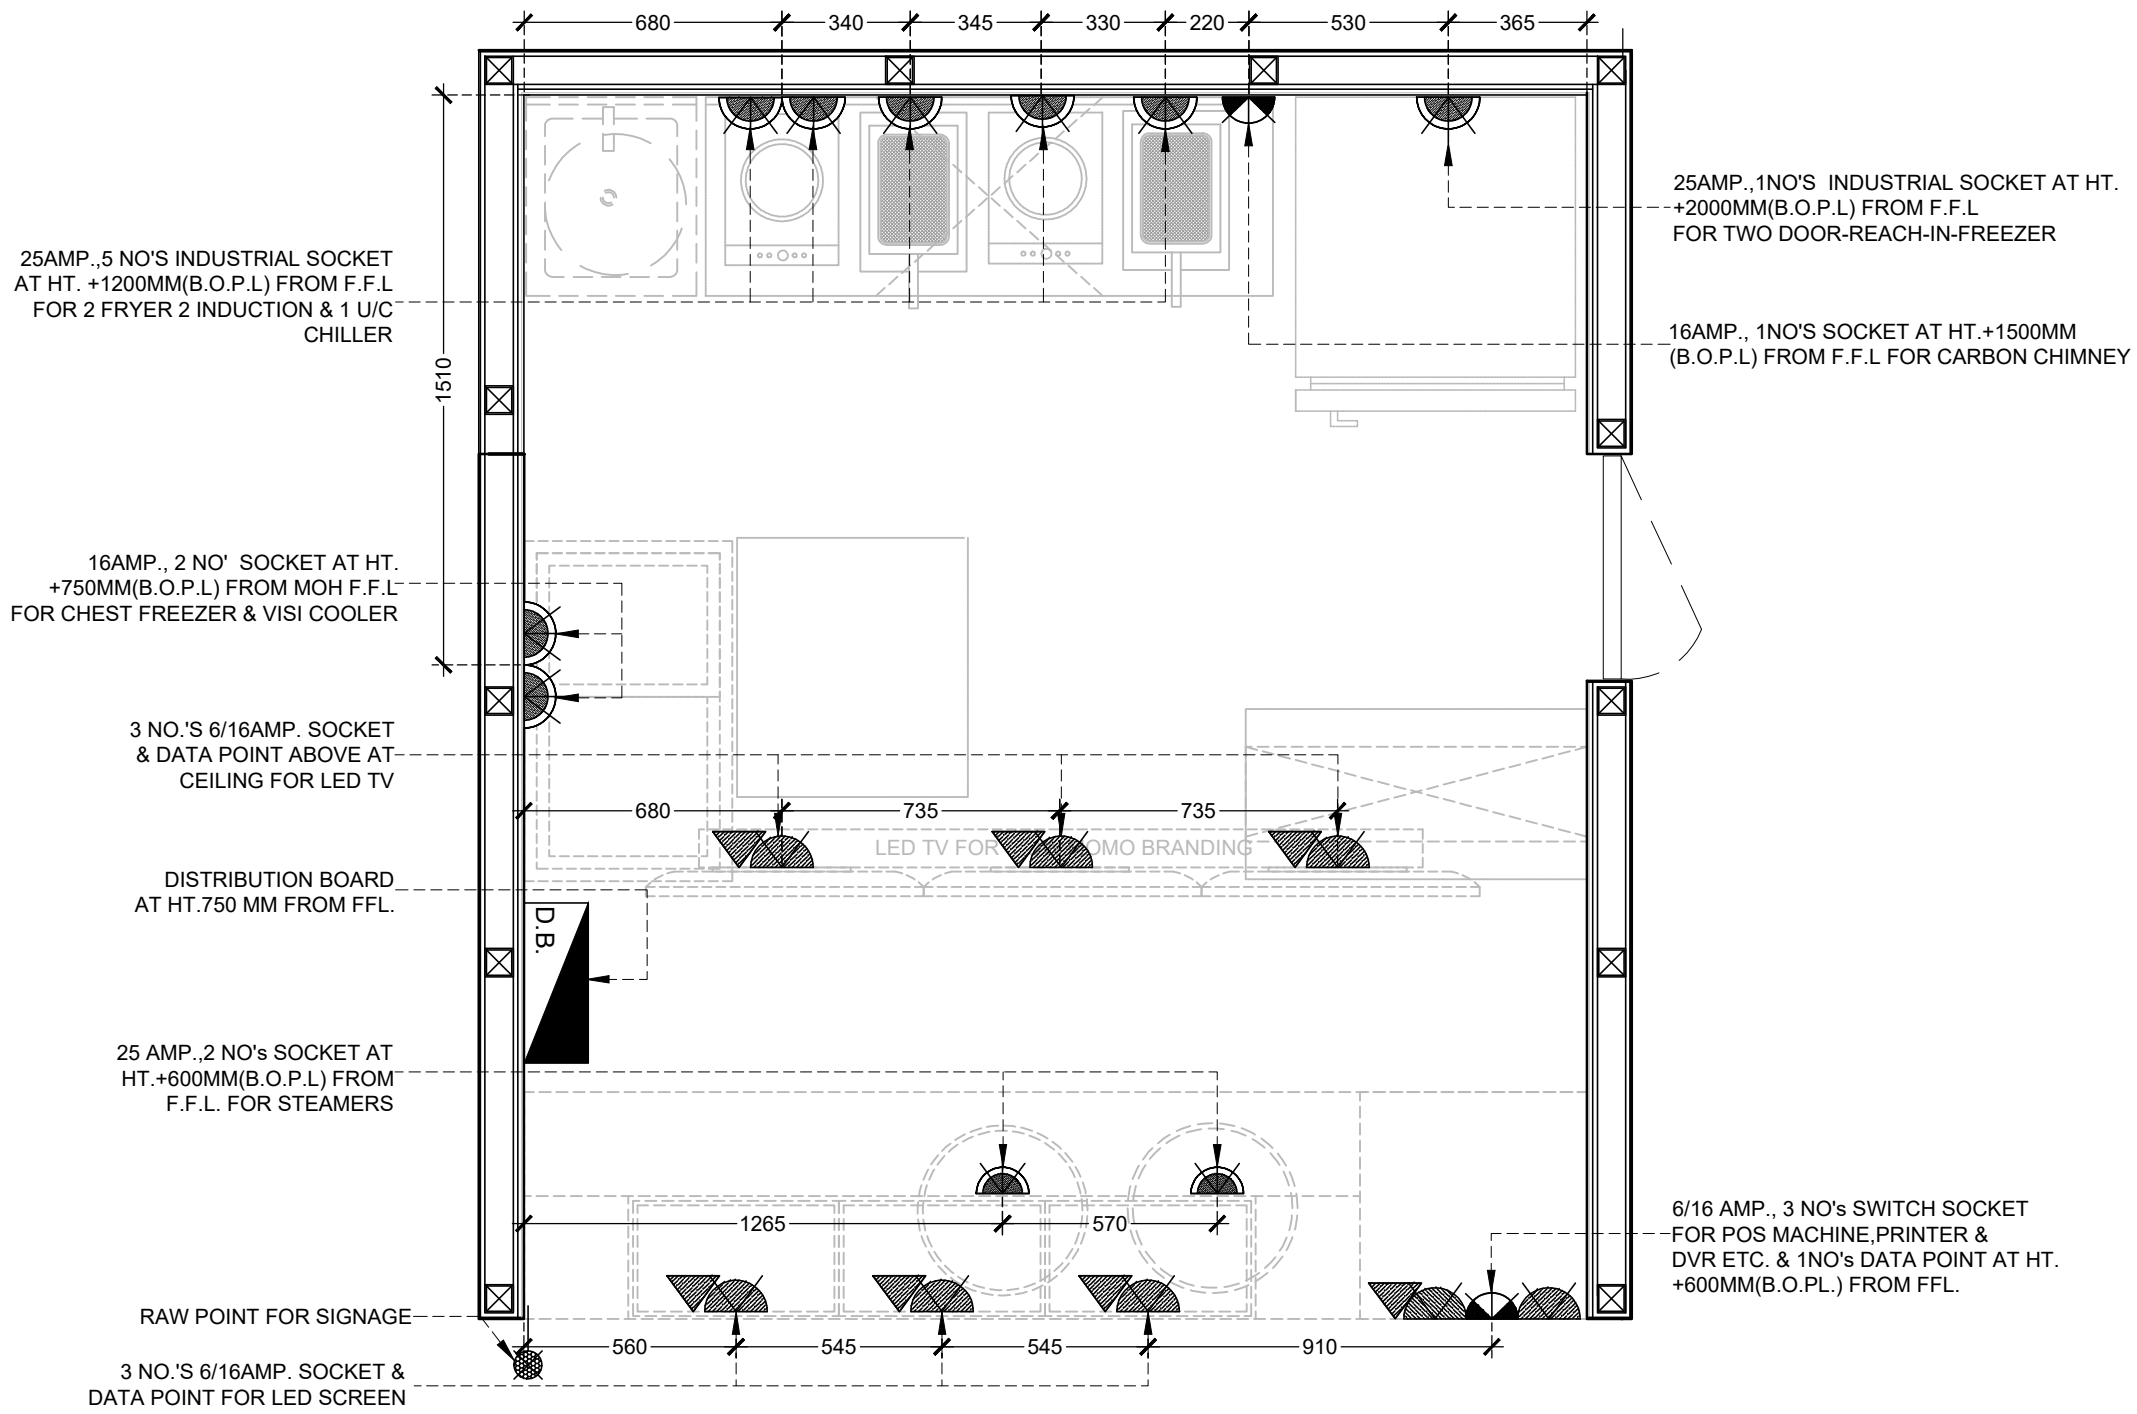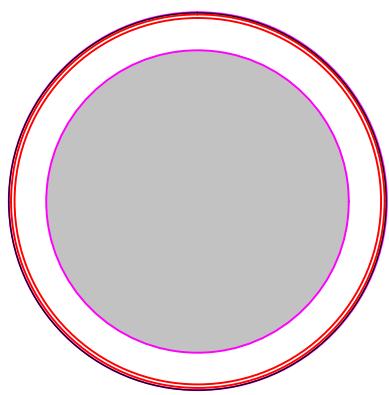

WALL ELECTRICAL LAYOUT

ELECTRICAL LEGEND		
1.		25 AMP INDUSTRIAL SOCKET
2.		16 AMP SOCKET
3.		6 AMP SOCKET
4.		DB(MCB)
5.		ELECTRICAL POINT

NOTE-

1. USE ONLY G.I. CONDUITS FOR WIRING.
2. STANDARD D.B. WITH NEUTRAL LINK ON EACH PHASE TO BE USED.
3. UPS CONNECTION AND PROVISION TO EMERGENCY LIGHTS, POS AND SIGNAGE SHOULD BE DONE.
4. ALL B.O.PL ARE FROM FLOOR FINISH LEVEL

PROJECT
WOW MOMO @ MUMBAI AIRPORT T-2.

CLIENT
WOW! MOMO FOODS PVT. LTD.

CONSULTANT
-

ARCHITECT / INTERIOR DESIGN

 FLAT NO-13 DDA SFS SLAT POCKET -1 SEC-6 DWARKA, NEW DELHI-110075
 EMAIL:-infoatats@gmail.com
 OFF-011-35559249, MOB:9910315171

TITLE
WALL ELECTRICAL LAYOUT

NOTE:
THIS DRAWING & DESIGN IS THE COPYRIGHT OF THE DESIGNER. NO PORTION MAY BE REPRODUCED WITHOUT THE WRITTEN PERMISSION OF THE DESIGNERS


1. ALL DIMENSIONS ARE INCLUDING FINISHES
2. DO NOT SCALE DRAWING. ONLY MENTIONED DIMENSIONS ARE TO BE CONSIDERED.
3. ALL DIMENSIONS MUST BE CHECKED BEFORE COMMENCING WORK ON SITE.
4. ANY DISCREPANCIES SHALL BE BROUGHT UNDER THE NOTICE OF ARCHITECTS PRIOR COMMENCEMENT OF WORK.

REVISION		
S.NO.	REMARKS	DATE
1	REV 1	00/00/00
2	REV 2	00/00/00
3	REV 3	00/00/00
4	REV 4	00/00/00
5	REV 5	00/00/00
6	REV 6	00/00/00
7	REV 7	00/00/00
8	REV 8	00/00/00

CONSULTANT
-

RELEASE FOR			
INFORMATION	TENDER	CONSTRUCTION	AS BUILT

DATE	05-10-2024
SCALE	NTS
DRAWN BY	PUSHPENDER
CHECKED BY	AR.MANISH
PRINTED BY	-
DWG. NO.	IA-105

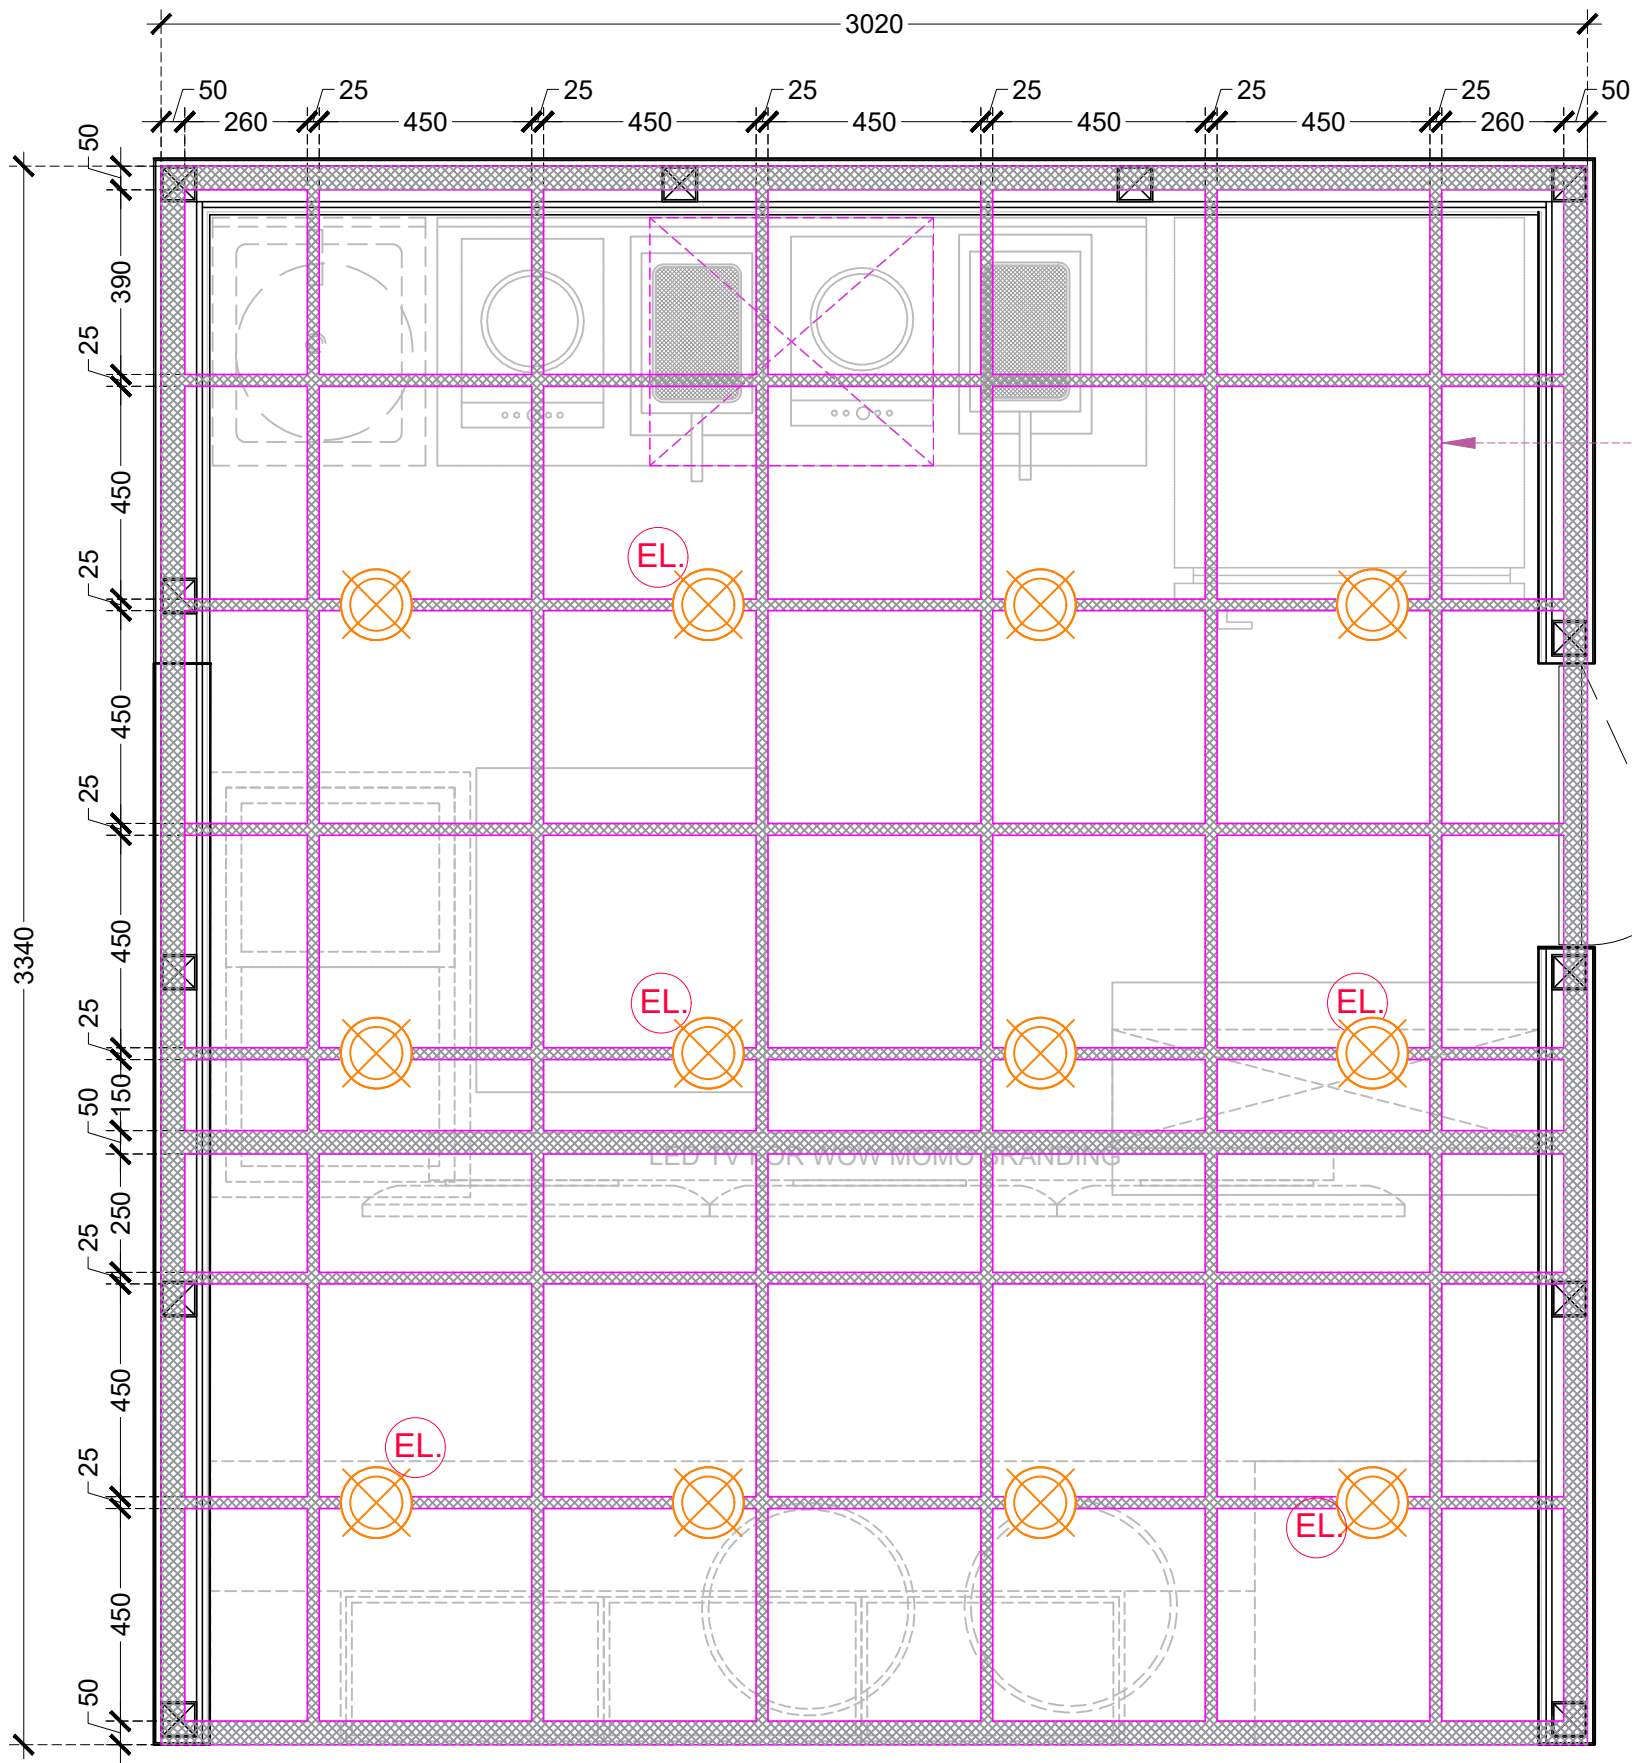

100X100MM MS FRAME
SUPPORT OVER 25X25MM MS
FRAME STRUCTURE
OPEN GRID CEILING OVER
FINISH WITH BLACK DUCO
PAINT

LIGHTING LEGEND		
S.NO.	DESCRIPTION	QTY.
⊗	150MM Ø SURFACE LIGHT	12
EL	EMEGENCY LIGHT	
⊠	CABLE TRAY	

REFLECTED CEILING PLAN

PROJECT
WOW MOMO @ MUMBAI
AIRPORT T-2.

CLIENT
WOW! MOMO FOODS PVT. LTD.

CONSULTANT
-

ARCHITECT / INTERIOR DESIGN

 FLAT NO-13 DDA SFS
SLAT POCKET -1 SEC-6
DWARKA,
NEW DELHI-110075
EMAIL:-infoatats@gmail.com
OFF-011-35559249,
MOB:9910315171

TITLE
REFLECTED CEILING LAYOUT

NOTE:
THIS DRAWING & DESIGN IS THE COPYRIGHT OF THE DESIGNER. NO PORTION MAY BE REPRODUCED WITHOUT THE WRITTEN PERMISSION OF THE DESIGNERS

1. ALL DIMENSIONS ARE INCLUDING FINISHES
2. DO NOT SCALE DRAWING. ONLY MENTIONED DIMENSIONS ARE TO BE CONSIDERED.
3. ALL DIMENSIONS MUST BE CHECKED BEFORE COMMENCING WORK ON SITE.
4. ANY DISCREPANCIES SHALL BE BROUGHT UNDER THE NOTICE OF ARCHITECTS PRIOR COMMENCEMENT OF WORK.


REVISION		
S.NO.	REMARKS	DATE
1	REV 1	00/00/00
2	REV 2	00/00/00
3	REV 3	00/00/00
4	REV 4	00/00/00
5	REV 5	00/00/00
6	REV 6	00/00/00
7	REV 7	00/00/00
8	REV 8	00/00/00

CONSULTANT
-

RELEASE FOR			
INFORMATION	TENDER	CONSTRUCTION	AS BUILT

DATE	05-10-2024
SCALE	NTS
DRAWN BY	PUSHPENDER
CHECKED BY	AR.MANISH
PRINTED BY	-
DWG. NO.	IA-106

V:\WOW MOMO\ARCHITECTURE\INTERIOR\AIRPORT T-2\DWG\LIGHTING\DWG TO PRINT

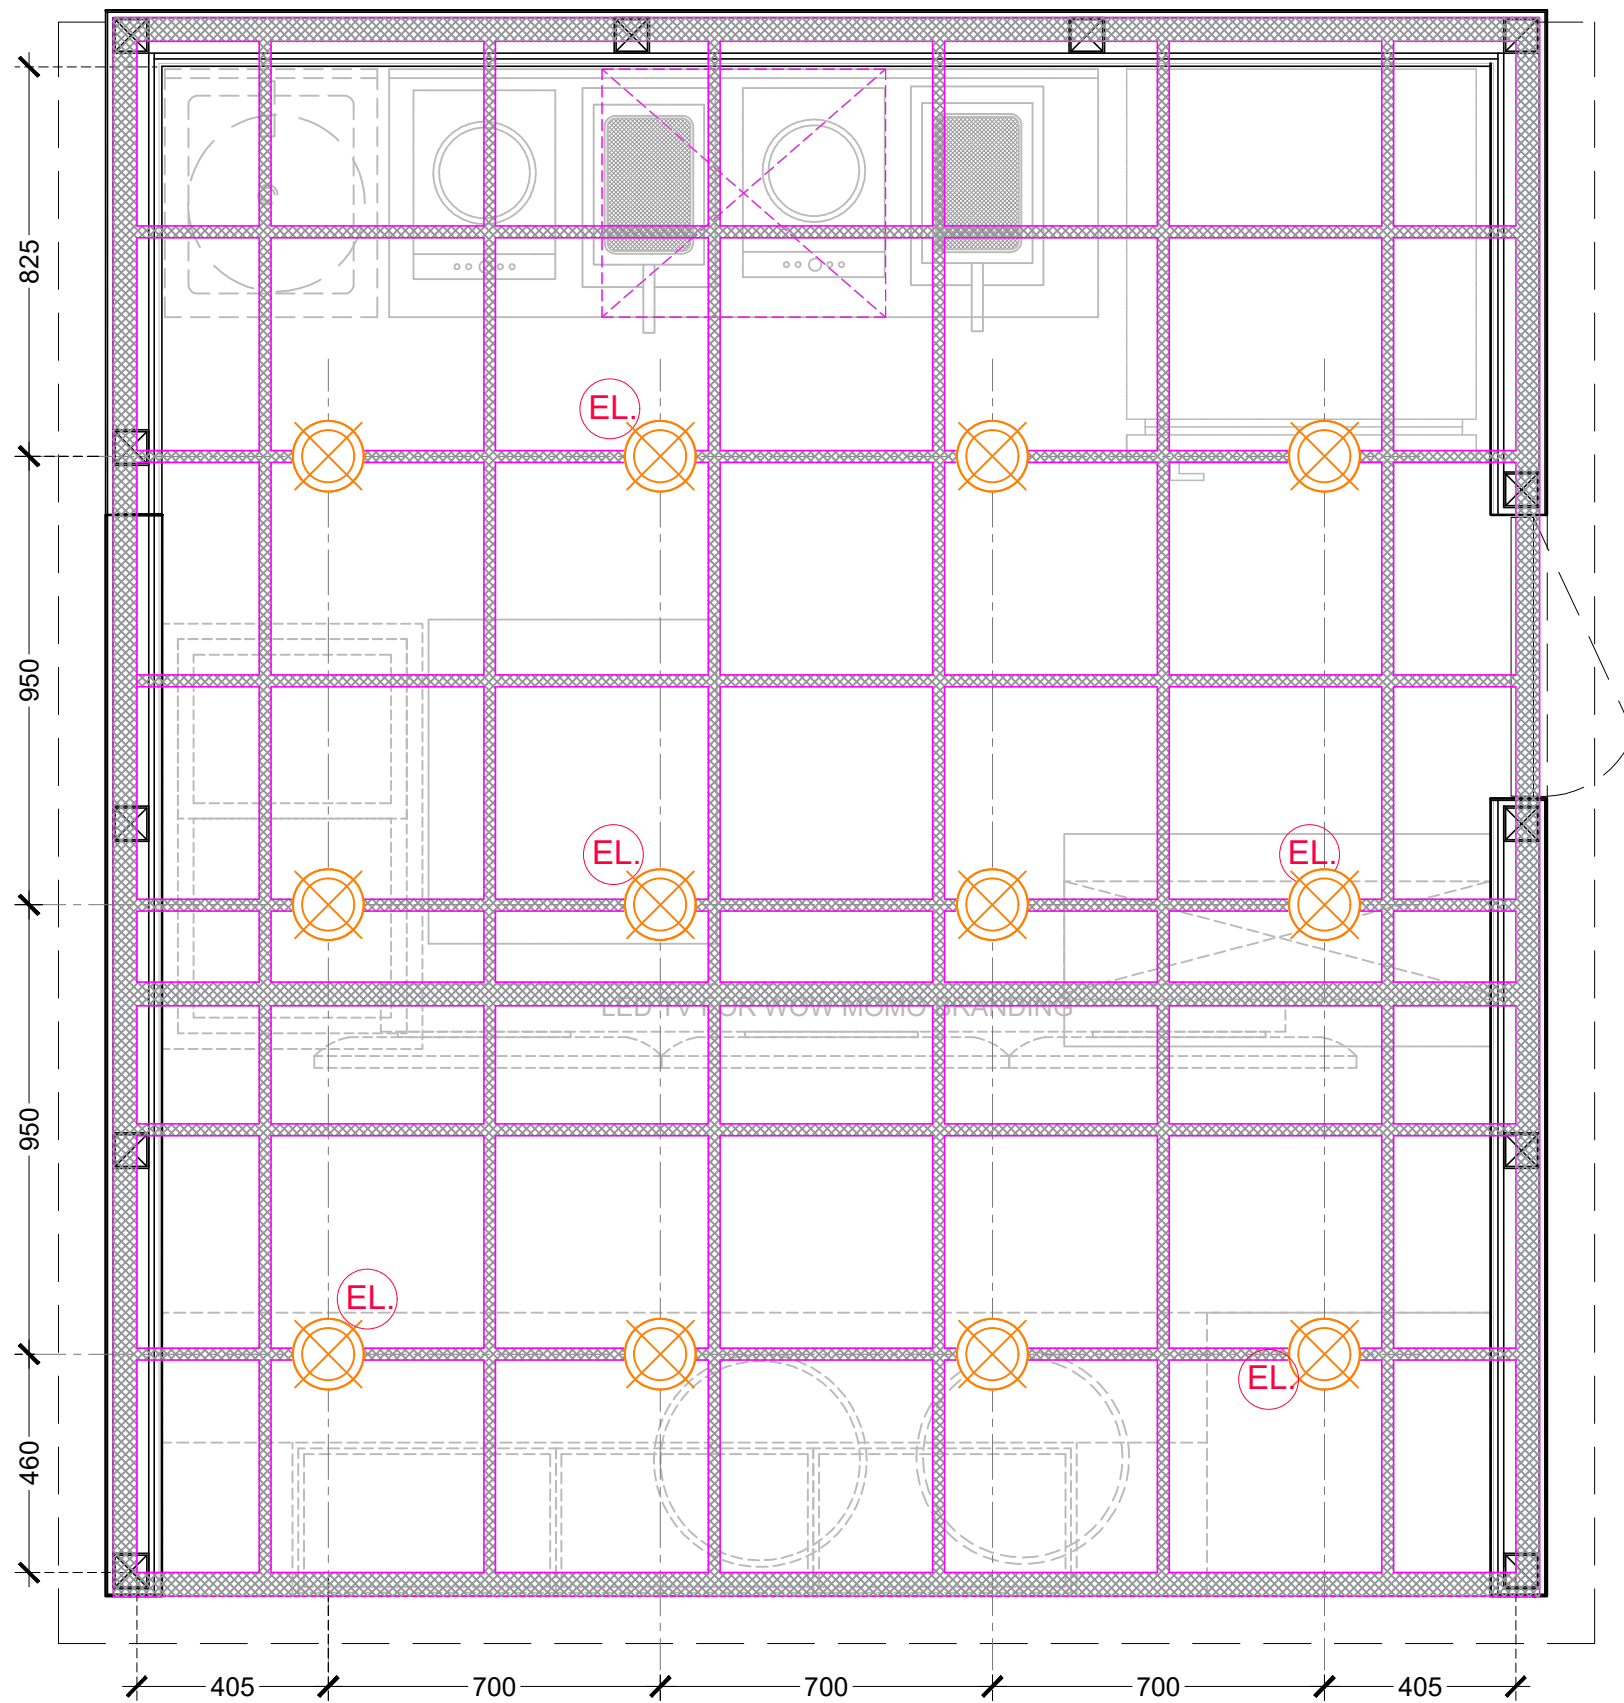

LIGHTING LAYOUT

LIGHTING LEGEND		
S.NO.	DESCRIPTION	QTY.
	150MM Ø SURFACE LIGHT	12
	EMEGENCY LIGHT	
	CABLE TRAY	

PROJECT
 WOW MOMO @ MUMBAI
 AIRPORT T-2.

CLIENT
 WOW! MOMO FOODS PVT. LTD.

CONSULTANT
 -

ARCHITECT / INTERIOR DESIGN

 FLAT NO-13 DDA SFS
 SLAT POCKET -1 SEC-6
 DWARKA,
 NEW DELHI-110075
 EMAIL:-infoatats@gmail.com
 OFF-011-35559249,
 MOB:9910315171

TITLE
 LIGHTING LAYOUT


NOTE:
 THIS DRAWING & DESIGN IS THE COPYRIGHT OF THE DESIGNER. NO PORTION MAY BE REPRODUCED WITHOUT THE WRITTEN PERMISSION OF THE DESIGNERS
 1. ALL DIMENSIONS ARE INCLUDING FINISHES
 2. DO NOT SCALE DRAWING. ONLY MENTIONED DIMENSIONS ARE TO BE CONSIDERED.
 3. ALL DIMENSIONS MUST BE CHECKED BEFORE COMMENCING WORK ON SITE.
 4. ANY DISCREPANCIES SHALL BE BROUGHT UNDER THE NOTICE OF ARCHITECTS PRIOR COMMENCEMENT OF WORK.

REVISION		
S.NO.	REMARKS	DATE
1	REV 1	00/00/00
2	REV 2	00/00/00
3	REV 3	00/00/00
4	REV 4	00/00/00
5	REV 5	00/00/00
6	REV 6	00/00/00
7	REV 7	00/00/00
8	REV 8	00/00/00

CONSULTANT
 -

RELEASE FOR			
INFORMATION	TENDER	CONSTRUCTION	AS BUILT

DATE	05-10-2024
SCALE	NTS
DRAWN BY	PUSHPENDER
CHECKED BY	AR.MANISH
PRINTED BY	-
DWG. NO.	IA-107

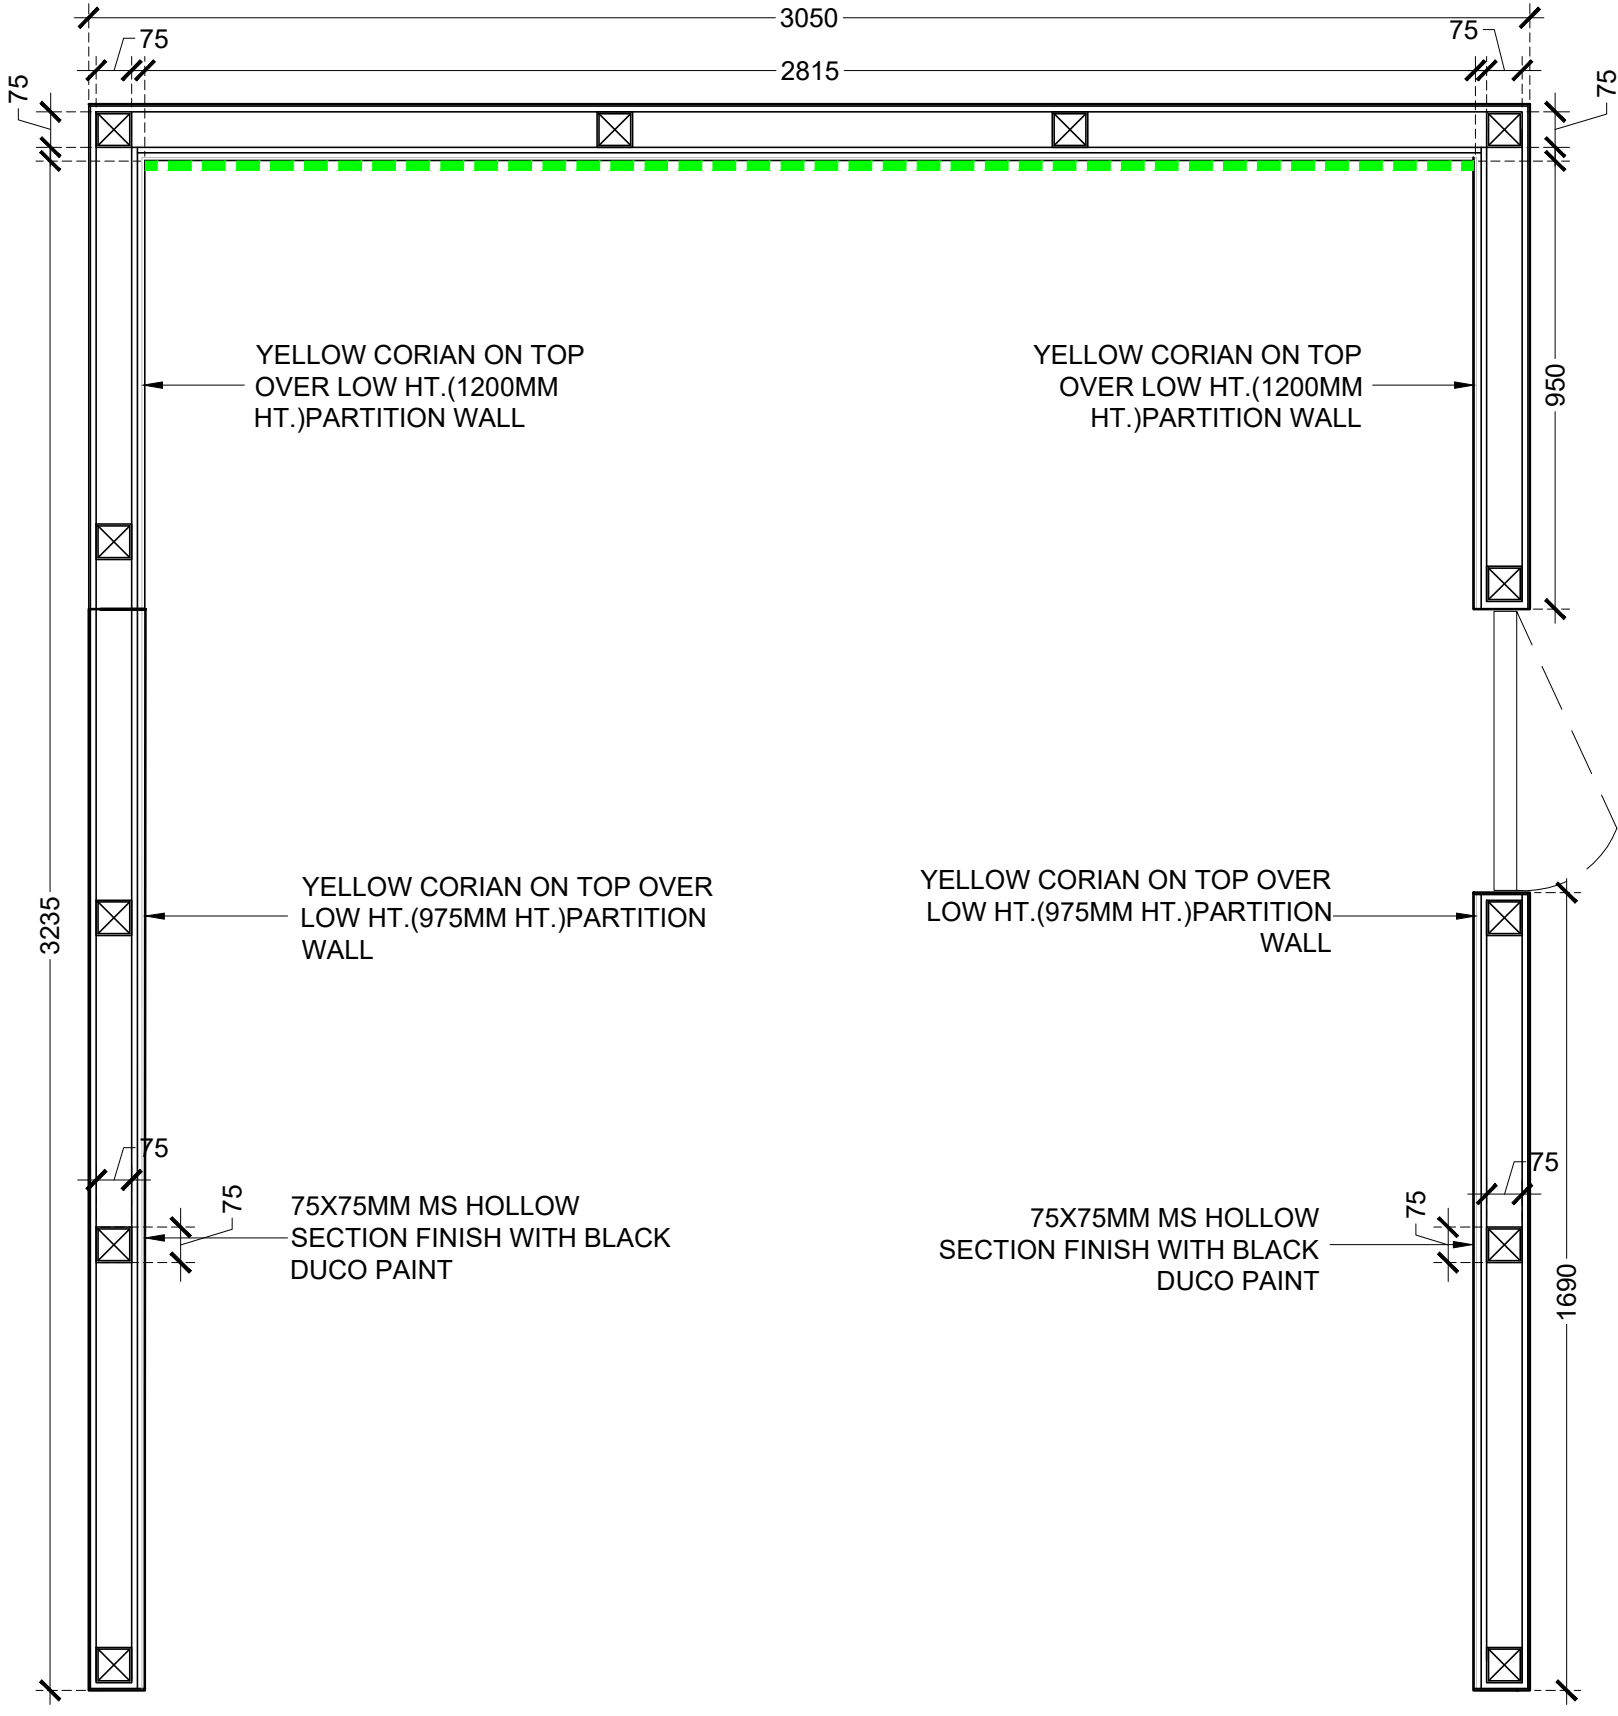


KIOSK AREA WALL FINISH

WALL FINISHED WITH 200 X100MM SUBWAY GREY & BLACK TILE (MAKE: JOHNSON) UPTO FULL HT.

WALL FINISHES LAYOUT

<p>PROJECT WOW MOMO @ MUMBAI AIRPORT T-2.</p>	<p>CLIENT WOW! MOMO FOODS PVT. LTD.</p>	<p>CONSULTANT -</p>	<p>ARCHITECT / INTERIOR DESIGN</p> <p style="font-size: small;"> ARCHITECTURE & INTERIOR DESIGN FLAT NO-13 DDA SFS SLAT POCKET -1 SEC-6 DWARKA, NEW DELHI-110075 EMAIL:-infoatats@gmail.com OFF-011-35559249, MOB:9910315171 </p>																																							
<p>NOTE: THIS DRAWING & DESIGN IS THE COPYRIGHT OF THE DESIGNER. NO PORTION MAY BE REPRODUCED WITHOUT THE WRITTEN PERMISSION OF THE DESIGNERS</p> <p>1. ALL DIMENSIONS ARE INCLUDING FINISHES 2. DO NOT SCALE DRAWING. ONLY MENTIONED DIMENSIONS ARE TO BE CONSIDERED. 3. ALL DIMENSIONS MUST BE CHECKED BEFORE COMMENCING WORK ON SITE. 4. ANY DISCREPANCIES SHALL BE BROUGHT UNDER THE NOTICE OF ARCHITECTS PRIOR COMMENCEMENT OF WORK.</p>	<p>REVISION</p> <table border="1" style="width: 100%; border-collapse: collapse; font-size: x-small;"> <thead> <tr> <th>S.NO.</th> <th>REMARKS</th> <th>DATE</th> </tr> </thead> <tbody> <tr><td>1</td><td>REV 1</td><td>00/00/00</td></tr> <tr><td>2</td><td>REV 2</td><td>00/00/00</td></tr> <tr><td>3</td><td>REV 3</td><td>00/00/00</td></tr> <tr><td>4</td><td>REV 4</td><td>00/00/00</td></tr> <tr><td>5</td><td>REV 5</td><td>00/00/00</td></tr> <tr><td>6</td><td>REV 6</td><td>00/00/00</td></tr> <tr><td>7</td><td>REV 7</td><td>00/00/00</td></tr> <tr><td>8</td><td>REV 8</td><td>00/00/00</td></tr> </tbody> </table>	S.NO.	REMARKS	DATE	1	REV 1	00/00/00	2	REV 2	00/00/00	3	REV 3	00/00/00	4	REV 4	00/00/00	5	REV 5	00/00/00	6	REV 6	00/00/00	7	REV 7	00/00/00	8	REV 8	00/00/00	<p>CONSULTANT -</p>	<p>TITLE WALL FINISH LAYOUT</p> <table border="1" style="width: 100%; border-collapse: collapse; font-size: x-small;"> <tr> <td>DATE</td> <td>05-10-2024</td> </tr> <tr> <td>SCALE</td> <td>NTS</td> </tr> <tr> <td>DRAWN BY</td> <td>PUSHPENDER</td> </tr> <tr> <td>CHECKED BY</td> <td>AR.MANISH</td> </tr> <tr> <td>PRINTED BY</td> <td>-</td> </tr> <tr> <td>DWG. NO.</td> <td>IA-108</td> </tr> </table>	DATE	05-10-2024	SCALE	NTS	DRAWN BY	PUSHPENDER	CHECKED BY	AR.MANISH	PRINTED BY	-	DWG. NO.	IA-108
S.NO.	REMARKS	DATE																																								
1	REV 1	00/00/00																																								
2	REV 2	00/00/00																																								
3	REV 3	00/00/00																																								
4	REV 4	00/00/00																																								
5	REV 5	00/00/00																																								
6	REV 6	00/00/00																																								
7	REV 7	00/00/00																																								
8	REV 8	00/00/00																																								
DATE	05-10-2024																																									
SCALE	NTS																																									
DRAWN BY	PUSHPENDER																																									
CHECKED BY	AR.MANISH																																									
PRINTED BY	-																																									
DWG. NO.	IA-108																																									
		<p>RELEASE FOR</p> <table border="1" style="width: 100%; border-collapse: collapse; font-size: x-small;"> <tr> <td>INFORMATION</td> <td>TENDER</td> <td>CONSTRUCTION</td> <td>AS BUILT</td> </tr> </table>	INFORMATION	TENDER	CONSTRUCTION	AS BUILT																																				
INFORMATION	TENDER	CONSTRUCTION	AS BUILT																																							

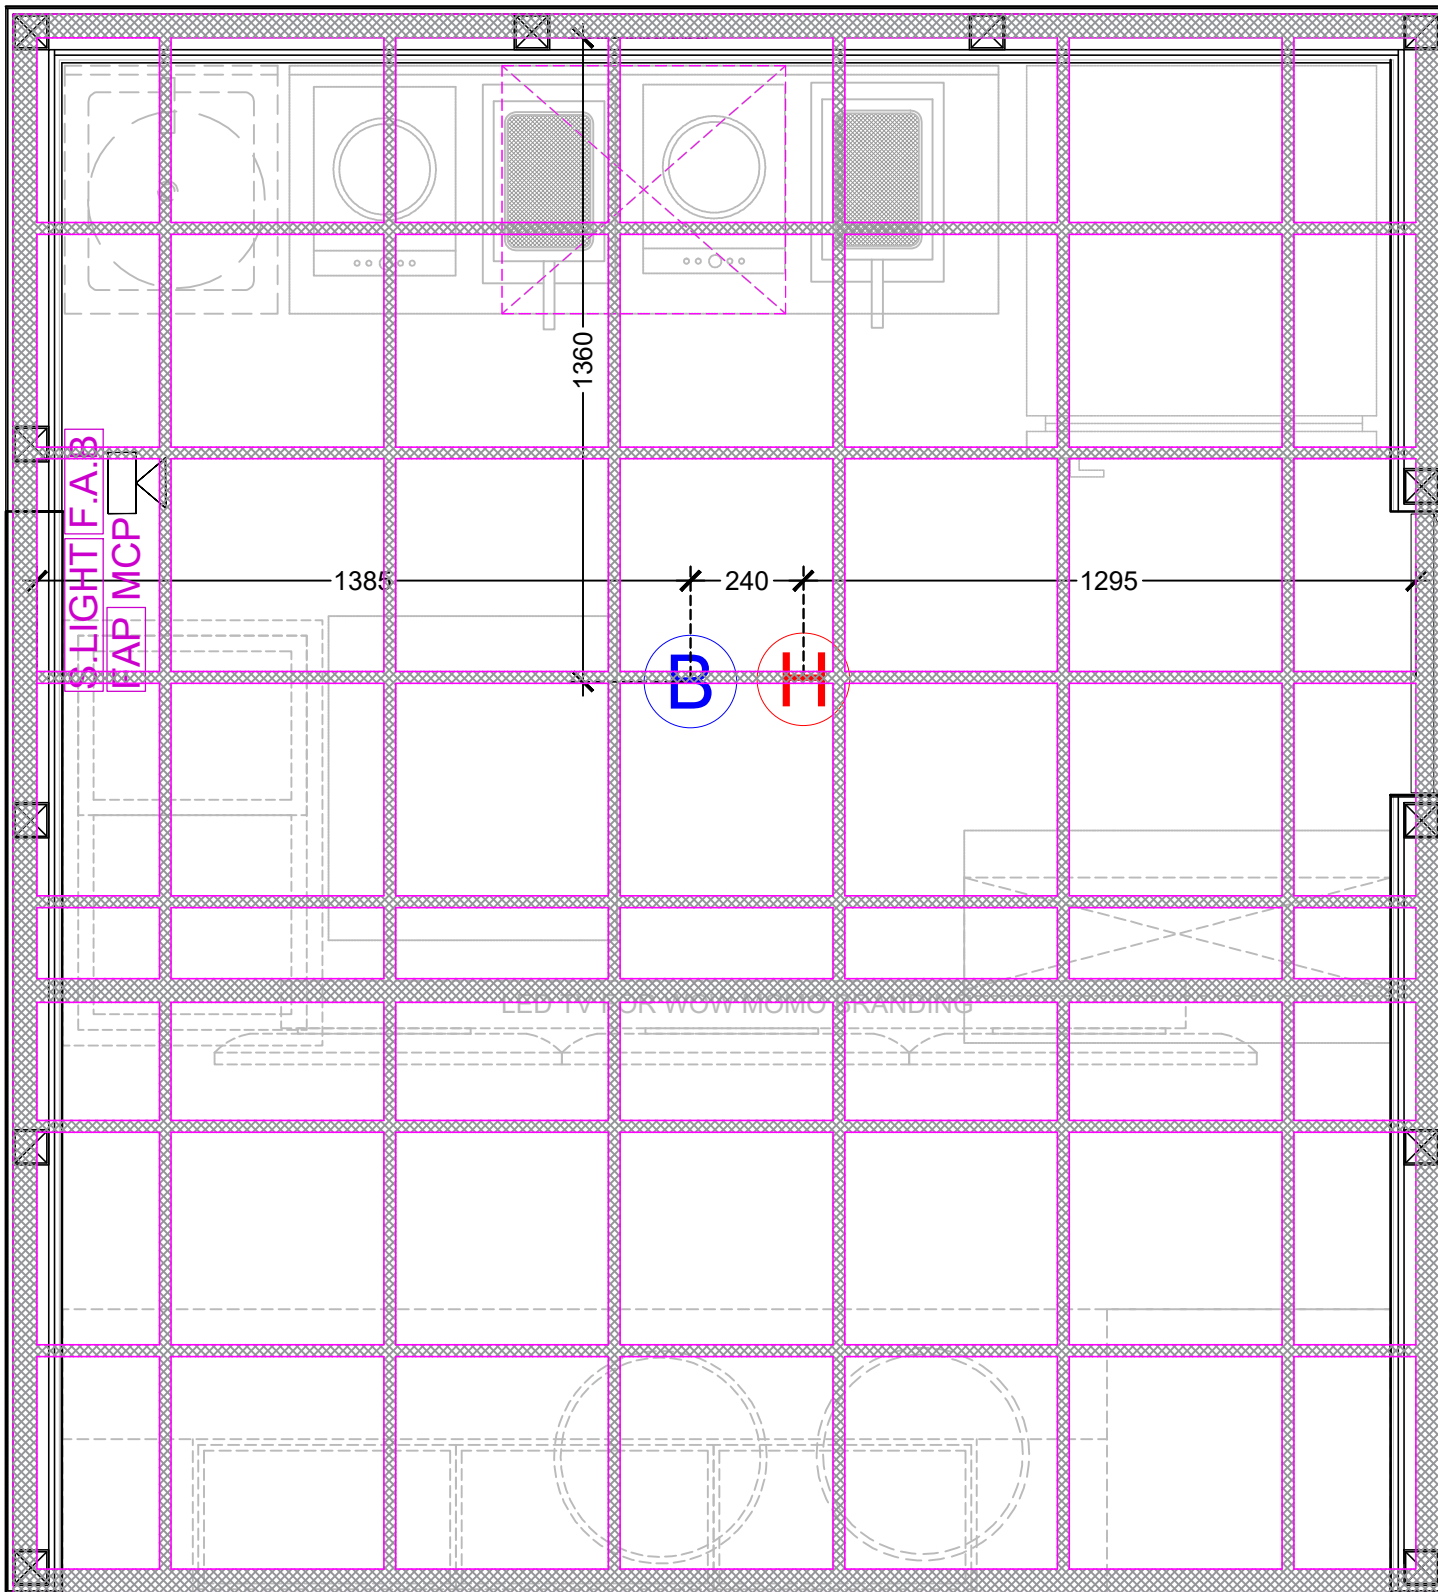

SMOKE DETECTOR LAYOUT

SMOKE DETECTOR LEGEND				
S.NO.	ITEMS	DESCRIPTION	QTY.	AREA COVERED
1.	B	SMOKE DETECTOR BELOW FALSE CEILING	01	250 SQ FT/ WITH IN 6M GRID
2.	H	CONVENTIONAL HEAT DETECTOR	01	250 SQ FT/ WITH IN 6M GRID
3.		HOOTER	01	
4.	MCP	MANUAL CALL POINT	01	
5.	FAP	FIRE ALARM PANEL	01	
6.	S.LIGHT	STROBE LIGHT	01	
7.	F.A.B	FIRST AID BOX	01	

PROJECT
WOW MOMO @ MUMBAI AIRPORT T-2.

CLIENT
WOW! MOMO FOODS PVT. LTD.

CONSULTANT
-

ARCHITECT / INTERIOR DESIGN

 FLAT NO-13 DDA SFS
 SLAT POCKET -1 SEC-6
 DWARKA,
 NEW DELHI-110075
 EMAIL:-infoatats@gmail.com
 OFF-011-35559249,
 MOB:9910315171

TITLE
SMOKE DETECTOR LAYOUT

NOTE:
THIS DRAWING & DESIGN IS THE COPYRIGHT OF THE DESIGNER. NO PORTION MAY BE REPRODUCED WITHOUT THE WRITTEN PERMISSION OF THE DESIGNERS

- ALL DIMENSIONS ARE INCLUDING FINISHES
- DO NOT SCALE DRAWING. ONLY MENTIONED DIMENSIONS ARE TO BE CONSIDERED.
- ALL DIMENSIONS MUST BE CHECKED BEFORE COMMENCING WORK ON SITE.
- ANY DISCREPANCIES SHALL BE BROUGHT UNDER THE NOTICE OF ARCHITECTS PRIOR COMMENCEMENT OF WORK.

REVISION


S.NO.	REMARKS	DATE
1	REV 1	00/00/00
2	REV 2	00/00/00
3	REV 3	00/00/00
4	REV 4	00/00/00
5	REV 5	00/00/00
6	REV 6	00/00/00
7	REV 7	00/00/00
8	REV 8	00/00/00

CONSULTANT
-

RELEASE FOR

INFORMATION	TENDER	CONSTRUCTION	AS BUILT

DATE	05-10-2024
SCALE	NTS
DRAWN BY	PUSHPENDER
CHECKED BY	AR.MANISH
PRINTED BY	-
DWG. NO.	IA-109

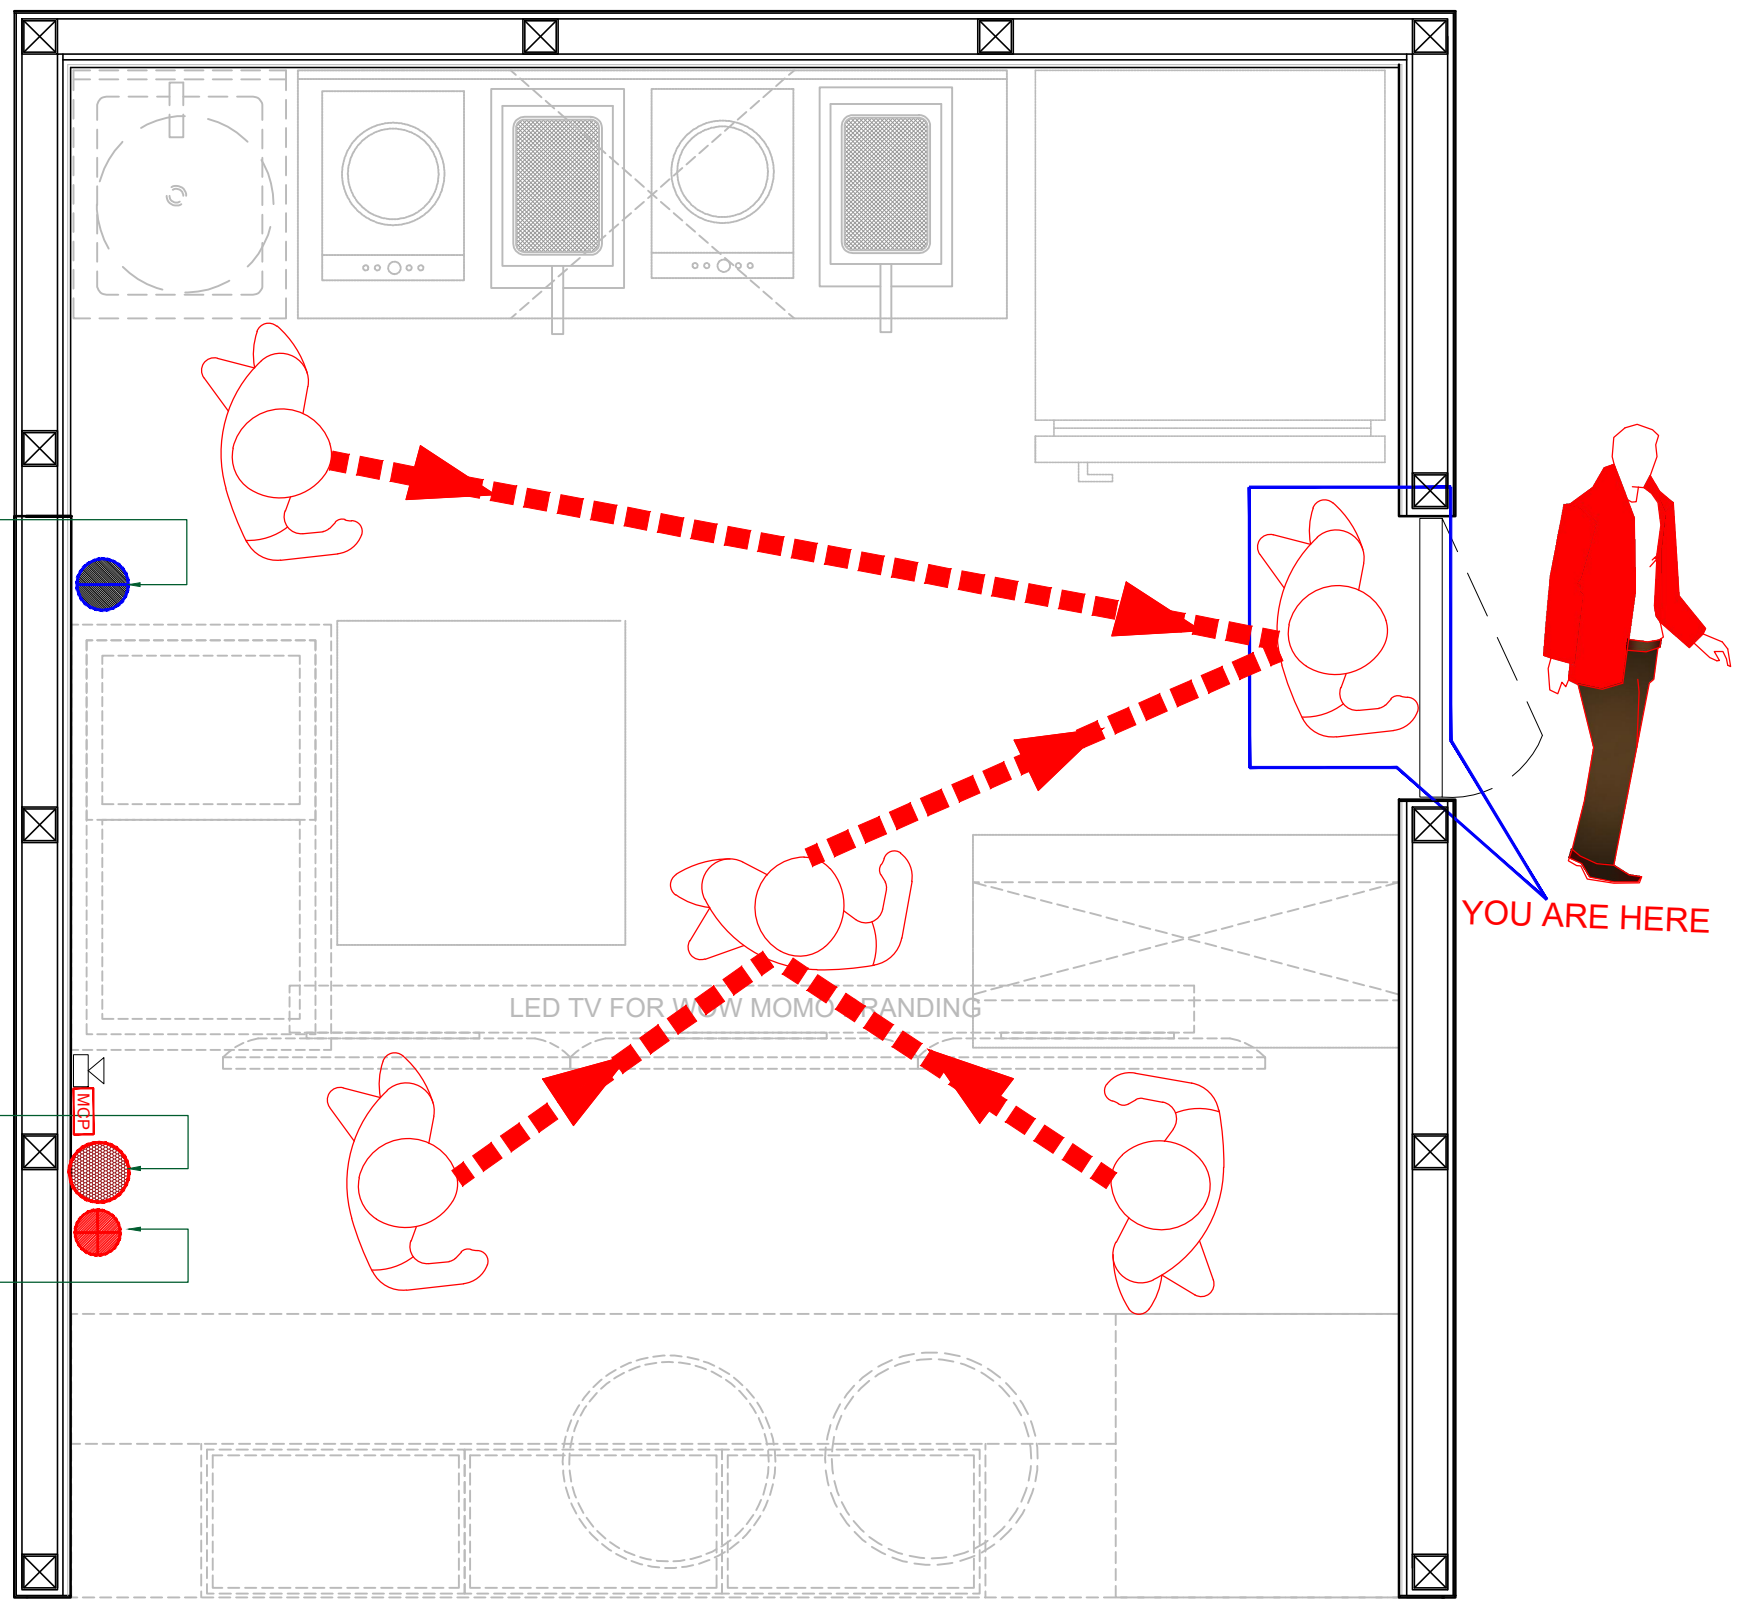

"K" TYPE 2KG

SAFEX ABC 4 1/2" KG

CO₂ TYPE 4 1/2"KG

LED TV FOR WOW MOMO BRANDING

YOU ARE HERE

FIRE LEGEND

	MANUAL CALL POINT
	HOOTER
	CO ₂ TYPE 4 1/2"KG
	"K" TYPE 2KG
	SAFEX ABC 4 1/2" KG

NOTE:-

1. FIRE EXTINGUISHER SHALL CONFIRM TO RELEVANT LATEST INDIAN STANDARD.
2. FIRE EXTINGUISHER SHALL BE HUNG ON BRACKETS WITH THEIR BOTTOM 750 MM ABOVE FLOOR LEVEL.
3. THE EXACT LOCATION OF FIRE EXTINGUISHERS SHALL BE AS/DRAWING.

FIRE EXTINGUISHER & EVACUATION LAYOUT

PROJECT
WOW MOMO @ MUMBAI
AIRPORT T-2.

CLIENT
WOW! MOMO FOODS PVT. LTD.

CONSULTANT
-

ARCHITECT / INTERIOR DESIGN

FLAT NO:-13 DDA SFS
SLAT POCKET -1 SEC-6
DWARKA,
NEW DELHI-110075
EMAIL:-infoatats@gmail.com
OFF-011-35559249,
MOB:9910315171

TITLE

FIRE EXTINGUISHER & EVACUATION LAYOUT

NOTE:-
THIS DRAWING & DESIGN IS THE COPYRIGHT OF THE DESIGNER. NO PORTION MAY BE REPRODUCED WITHOUT THE WRITTEN PERMISSION OF THE DESIGNERS

1. ALL DIMENSIONS ARE INCLUDING FINISHES
2. DO NOT SCALE DRAWING. ONLY MENTIONED DIMENSIONS ARE TO BE CONSIDERED.
3. ALL DIMENSIONS MUST BE CHECKED BEFORE COMMENCING WORK ON SITE.
4. ANY DISCREPANCIES SHALL BE BROUGHT UNDER THE NOTICE OF ARCHITECTS PRIOR COMMENCEMENT OF WORK.

REVISION

S.NO.	REMARKS	DATE
1	REV 1	00/00/00
2	REV 2	00/00/00
3	REV 3	00/00/00
4	REV 4	00/00/00
5	REV 5	00/00/00
6	REV 6	00/00/00
7	REV 7	00/00/00
8	REV 8	00/00/00

CONSULTANT
-

RELEASE FOR

INFORMATION | TENDER | CONSTRUCTION | AS BUILT

DATE 05-10-2024


SCALE NTS

DRAWN BY PUSHPENDER


CHECKED BY AR.MANISH

PRINTED BY -

DWG. NO. IA-110

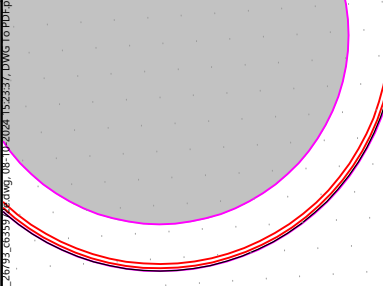

V:\WOW MOMO\ARCHITECTURE\INTERIOR\AIRPORT T-2\DWG\132237.DWG (10/10/2024)

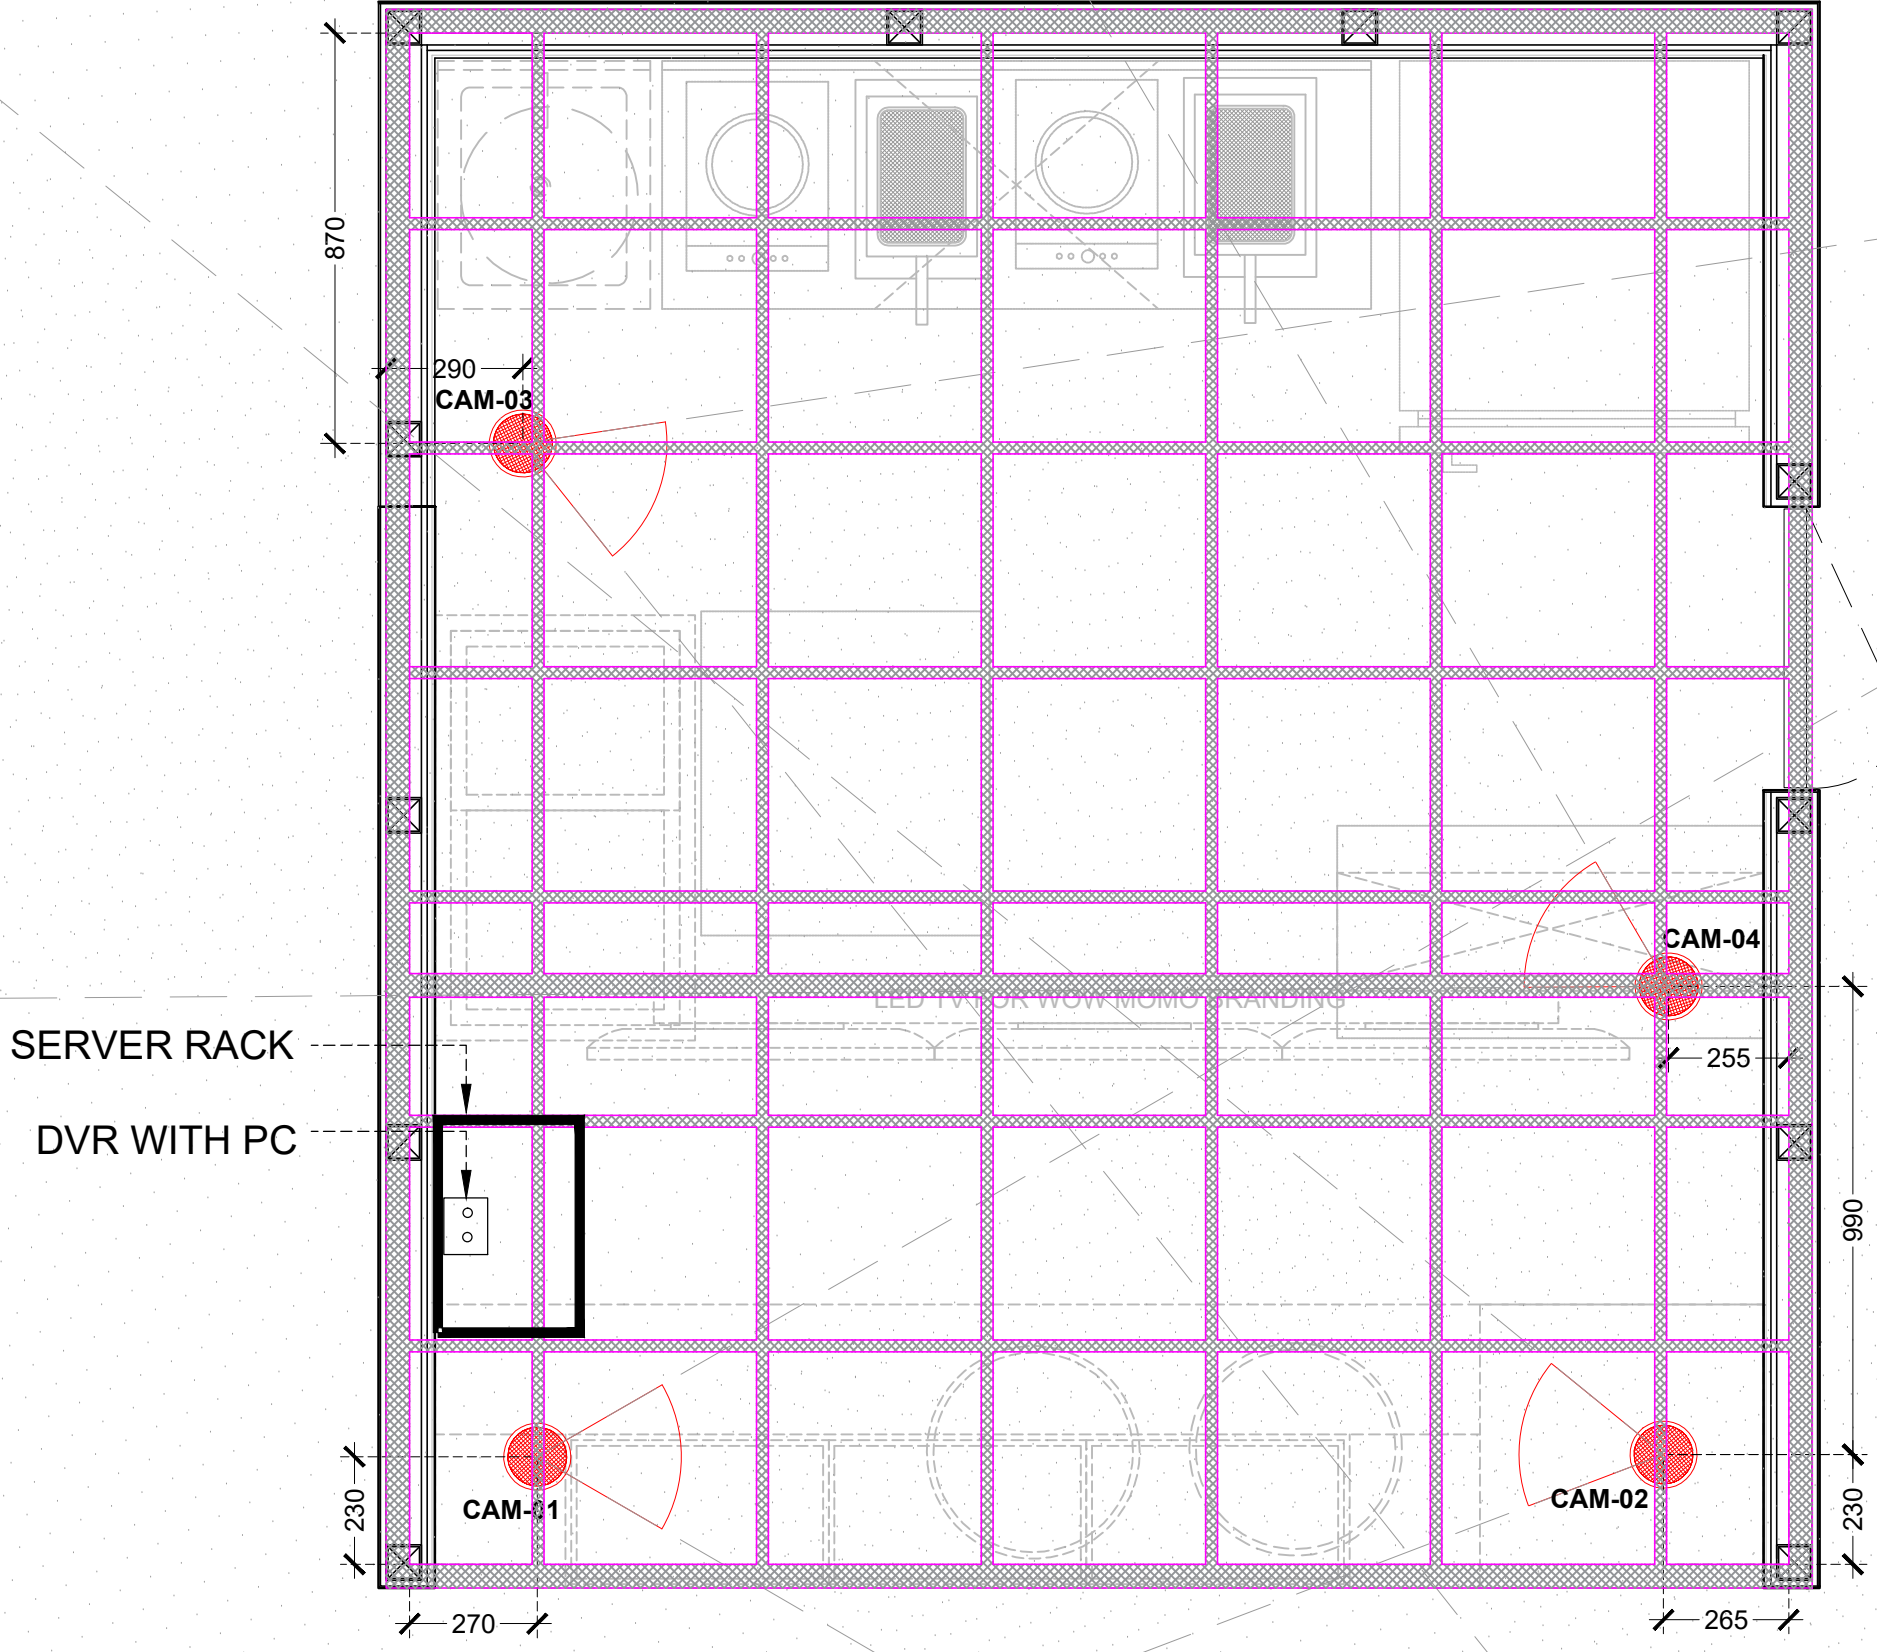


CCTV LAYOUT

CCTV LEGEND		
S.NO.	DESCRIPTION	QTY.
1	NIGHT VISION CAMERA	04
2	DVR WITH PC	01
3	MONITOR	01
4	SERVER RACK	01

PROJECT
WOW MOMO @ MUMBAI AIRPORT T-2.

CLIENT
WOW! MOMO FOODS PVT. LTD.

CONSULTANT

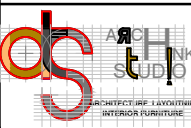ARCHITECT / INTERIOR DESIGN

 FLAT NO-13 DDA SFS
 SLAT POCKET -1 SEC-6
 DWARKA,
 NEW DELHI-110075
 EMAIL:-infoatats@gmail.com
 OFF-011-35559249,
 MOB:9910315171

TITLE
CCTV LAYOUT

NOTE:
 THIS DRAWING & DESIGN IS THE COPYRIGHT OF THE DESIGNER. NO PORTION MAY BE REPRODUCED WITHOUT THE WRITTEN PERMISSION OF THE DESIGNERS
 1. ALL DIMENSIONS ARE INCLUDING FINISHES
 2. DO NOT SCALE DRAWING. ONLY MENTIONED DIMENSIONS ARE TO BE CONSIDERED.
 3. ALL DIMENSIONS MUST BE CHECKED BEFORE COMMENCING WORK ON SITE.
 4. ANY DISCREPANCIES SHALL BE BROUGHT UNDER THE NOTICE OF ARCHITECTS PRIOR COMMENCEMENT OF WORK.


REVISION		
S.NO.	REMARKS	DATE
1	REV 1	00/00/00
2	REV 2	00/00/00
3	REV 3	00/00/00
4	REV 4	00/00/00
5	REV 5	00/00/00
6	REV 6	00/00/00
7	REV 7	00/00/00
8	REV 8	00/00/00

CONSULTANT

RELEASE FOR			
INFORMATION	TENDER	CONSTRUCTION	AS BUILT

DATE	05-10-2024
SCALE	NTS
DRAWN BY	PUSHPENDER
CHECKED BY	AR.MANISH
PRINTED BY	-
DWG. NO.	IA-111

V:\WOW MOMO\AIRPORT T-2\COORDINATE LAYOUT.dwg, 10-20-2024, 10:52:21 AM, DWG TO PDF

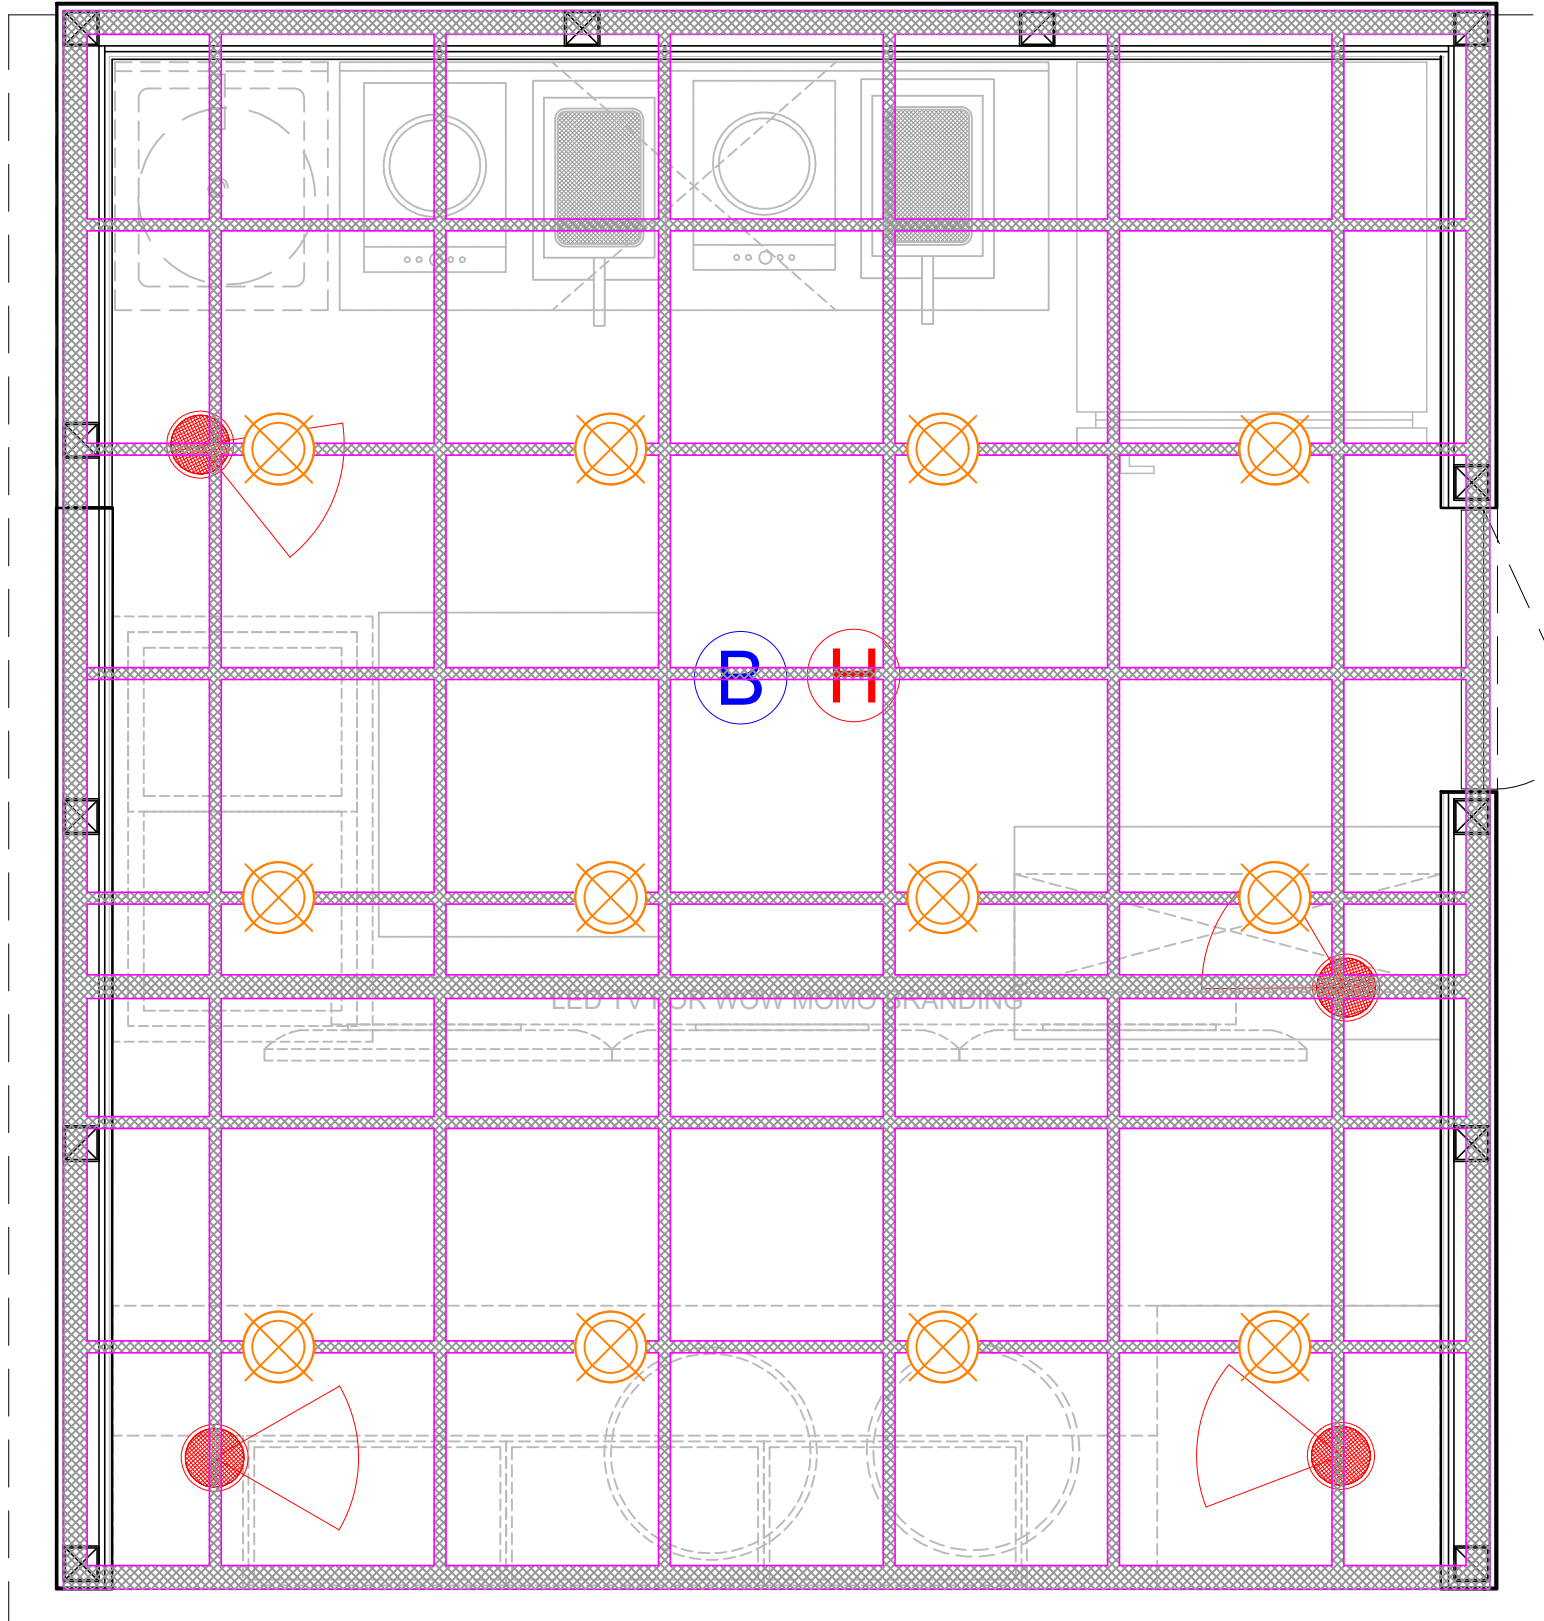

CCTV LEGEND		
S.NO.	DESCRIPTION	QTY.
	NIGHT VISION CAMERA	04
	DVR WITH PC	01
	MONITOR	01
	SERVER RACK	01

LIGHTING LEGEND		
S.NO.	DESCRIPTION	QTY.
	150MM Ø SURFACE LIGHT	12
	EMEGENCY LIGHT	
	CABLE TRAY	

SMOKE DETECTOR LEGEND				
S.NO.	ITEMS	DESCRIPTION	QTY.	
1.		SMOKE DETECTOR BELOW FALSE CEILING	01	2 II
2.		CONVENTIONAL HEAT DETECTOR	01	2 II

COORDINATE LAYOUT

PROJECT
WOW MOMO @ MUMBAI AIRPORT T-2.

CLIENT
WOW! MOMO FOODS PVT. LTD.

CONSULTANT
-

ARCHITECT / INTERIOR DESIGN

FLAT NO-13 DDA SFS SLAT POCKET -1 SEC-6 DWARKA, NEW DELHI-110075
EMAIL:-infoatats@gmail.com
OFF-011-35559249, MOB:9910315171

TITLE
COORDINATE LAYOUT

NOTE:
THIS DRAWING & DESIGN IS THE COPYRIGHT OF THE DESIGNER. NO PORTION MAY BE REPRODUCED WITHOUT THE WRITTEN PERMISSION OF THE DESIGNERS

1. ALL DIMENSIONS ARE INCLUDING FINISHES
2. DO NOT SCALE DRAWING. ONLY MENTIONED DIMENSIONS ARE TO BE CONSIDERED.
3. ALL DIMENSIONS MUST BE CHECKED BEFORE COMMENCING WORK ON SITE.
4. ANY DISCREPANCIES SHALL BE BROUGHT UNDER THE NOTICE OF ARCHITECTS PRIOR COMMENCEMENT OF WORK.

REVISION		
S.NO.	REMARKS	DATE
1	REV 1	00/00/00
2	REV 2	00/00/00
3	REV 3	00/00/00
4	REV 4	00/00/00
5	REV 5	00/00/00
6	REV 6	00/00/00
7	REV 7	00/00/00
8	REV 8	00/00/00

CONSULTANT
-

RELEASE FOR			
INFORMATION	TENDER	CONSTRUCTION	AS BUILT


DATE	05-10-2024
SCALE	NTS
DRAWN BY	PUSHPENDER
CHECKED BY	AR.MANISH
PRINTED BY	-
DWG. NO.	IA-112

LOAD CALCULATION FOR WOW MOMO @ MUMBAI AIRPORT T-2 KIOSK.

LOAD CALCULATION FOR WOW MOMO @ MUMBAI AIRPORT T-2 KIOSK.										
A	PLDB -12 W TPN DB									
	INCOMING CABLE - 4 *16 SQ.MM AL AR CABLE									
	INCOMING MCB -63 A TPN MCB									
S.NO	EQUIPMENT DETAILS	CIRCUIT N.O(SP/DP/TP) (DB-1,2,3)	QTY	LOAD KW	TOTAL LOAD IN KW			TOTAL LOAD	MCB RATING	SOCKET TYPE
					R-PHASE	Y-PHASE	B-PHASE	KW		
1	U/C CHILLER	B1 (SP)	1	1.2			1.2	1.2	25 A SP	25 A IND socket ,3 Pin.
2	FRYER	R1, Y1 (DP)	2	2	2	2		4	25 A DP	25 A IND socket ,3 Pin.
3	INDUCTION	R2,B2, (DP)	2	1.5	1.5			3	25 A DP	25 A IND socket 3 Pin
4	CEILING LIGHT	B3(as shown in drawing)(SP)	12	0.015			0.18	0.18	10 A SP	N.A
5	MAIN SIGNAGE	R3,Y2,B4(TP)	3	0.25	0.25	0.25	0.25	0.75	16 A TP	16 A Sw socket ,6 Pin.
6	VISI COOLER CELFROST FKG40(400 Ltr	Y3 (SP)	1	0.75		0.75		0.75	16 A SP	16 A Sw socket ,6 Pin.
7	CHEST FREEZER	R4 (SP)	1	1	1			1	16 A SP	16 A Sw socket ,6 Pin.
8	STEAMERS	R5 ,B5 (DP)	2	1.2	1.2		1.2	2.4	25 A DP	16 A Sw socket ,6 Pin.
9	TWO DOOR REACH-IN-FREEZER	B6 (SP)	1	1.2			1.2	1.2	25 A SP	26 A IND socket ,3 Pin.
10	CARBON CHIMNEY	Y4 (SP)	1	0.5		0.5		0.5	16 A SP	16 A Sw socket ,6 Pin.
11	UPS	Y5 (SP)	1	1.875		1.875		1.875	16 A SP	16 A Sw socket ,6 Pin.
	TOTAL			11.49	5.95	5.375	5.53	16.855		
B	UPS DB (1.0 KVA UPS)									
	UPS DB - 12 WAY SPN TYPE									
	INCOMING CABLE - 2 * 6 SQ.MM Cu Cu wires + 1*6 Sqmm earth wire									
	INCOMING MCB - 32 A DP MCB									
S.NO	EQUIPMENT DETAILS	CIRCUIT N.O	QTY	LOAD KW	TOTAL LOAD KW	MCB RATING				
1	POS		1	0.3	0.3	10 A SP				
2	Fire Panel		1	0.1	0.1	10 A SP				
3	CCTV Cameras		4	0.2	0.8	10 A SP				
5	EMERGENCY LIGHT	as shown in drawing	5	0.015	0.075	10 A SP				
7	LED TV	as shown in drawing	6	0.1	0.6	10 A SP				
	TOTAL				1.875					
S.NO.	DESCRIPTION OF LOAD	CONNECTED LOAD IN KW	DIVERSITY FACTOR	DEMAND LOAD IN KW						
A	PDB	16.86	0.8	13.48						
B	UPSDB (1.0 KVA UPS)	1.88	1	1.88						
	TOTAL LOAD IN KW	18.73		15.36						
	CONSIDER POWER FACTOR	0.7		0.7						
	LOAD IN KVA	26.76		21.94						

NOTES:-

- 1) ALL ELCB USED WILL BE OF 30 mA RATING ONLY.
- 2) ALL CONDUITS USED WILL BE MS CONDUITS ONLY.
- 3) ALL WIRES AND CABLES WILL BE CU FRLS WIRES & CABLES ONLY.
- 4) ALL POWER SOCKETS WILL BE WITH SHUTTER MECHANISM.
- 5) EXIT LIGHTS BE PROVIDED & SUPPLIED THROUGH UPS CIRCUIT.
- 6) EMERGENCY & EXIT LIGHTS SHOULD BE WIRED WITH FIRE RATED CABLE.
- 7) ALL SINGLE -PHASE WIRING SHALL BE WITH FRLC PVC INSULATED WIRES HAVING PHASE, NEUTRAL AND EARTH.
- 8) SIGNAGE ,FA PANEL ,CASH COUNTER ,OTHER CRITICAL EQUIPMENT SHALL BE LOOPED ON UPS CIRCUITS
- 9) 2*6 SQ MM CU WIRES +2*5 SQMM EARTH WIRE.FRLS PVC INSULATED CABLE.

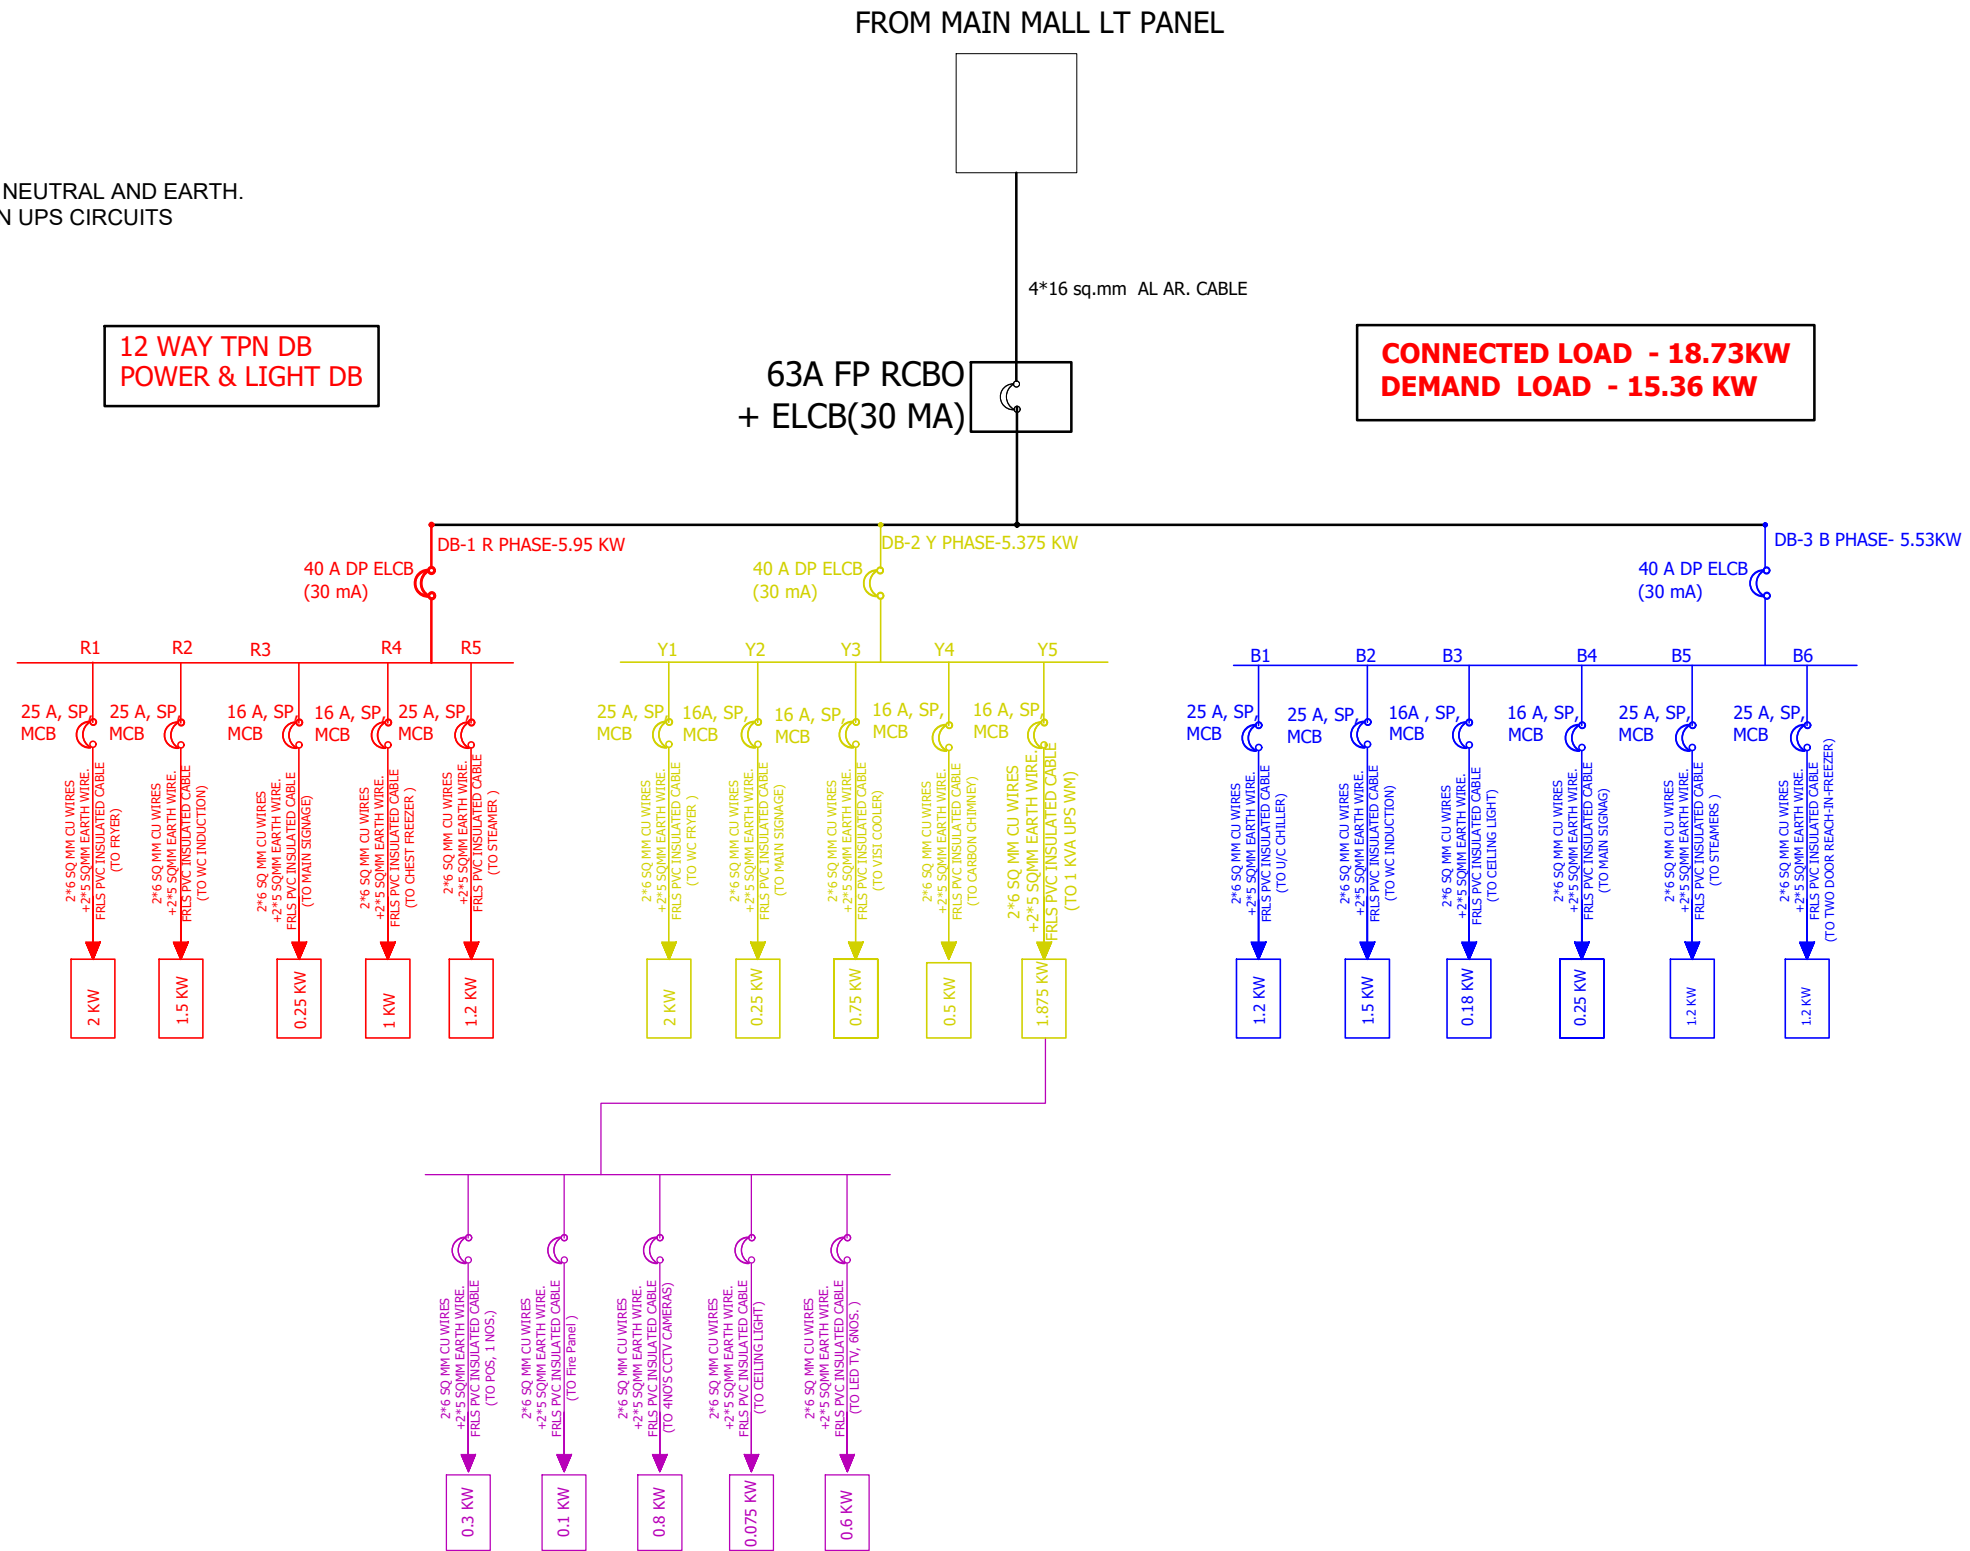

SINGLE LINE DIAGRAM

PROJECT WOW MOMO @ MUMBAI AIRPORT T-2 KIOSK.
CLIENT WOW MOMO FOODS PVT. LTD.

NOTE:
THIS DRAWING & DESIGN IS THE COPYRIGHT OF THE DESIGNER. NO PORTION MAY BE REPRODUCED WITHOUT THE WRITTEN PERMISSION OF THE DESIGNERS
1. ALL DIMENSIONS ARE INCLUDING FINISHES
2. DO NOT SCALE DRAWING. ONLY MENTIONED DIMENSIONS ARE TO BE CONSIDERED.
3. ALL DIMENSIONS MUST BE CHECKED BEFORE COMMENCING WORK ON SITE.
4. ANY DISCREPANCIES SHALL BE BROUGHT UNDER THE NOTICE OF ARCHITECTS PRIOR COMMENCEMENT OF WORK.

REVISION		
S.NO.	REMARKS	DATE
1	REV 1	00/00/00
2	REV 2	00/00/00
3	REV 3	00/00/00
4	REV 4	00/00/00
5	REV 5	00/00/00
6	REV 6	00/00/00
7	REV 7	00/00/00
8	REV 8	00/00/00

ARCHITECT / INTERIOR DESIGN

ARCHITECTURE PLANNING
INTERIOR FURNITURE

FLAT NO-13 DDA SFS
FLAT POCKET -1 SEC-6 DWARKA,
NEW DELHI-110075
EMAIL:-infoatats@gmail.com
OFF-011-35559249,MOB:9910315171

CONSULTANT

CONSULTANT

RELEASE FOR			
INFORMATION	TENDER	CONSTRUCTION	AS BUILT

TITLE			
SINGLE LINE DIAGRAM ELECTRICAL SYSTEM			
DATE	08-10-2024	CHECKED BY	AR.MANISH
SCALE	N.T.S.	PRINTED BY	---
DWG. NO.	IA-114	DRAWN BY	PUSHPENDER


PROJECT
WOW MOMO @ MUMBAI AIRPORT T-2.

CLIENT
 WOW! MOMO FOODS PVT. LTD.

NOTE:
 THIS DRAWING & DESIGN IS THE COPYRIGHT OF THE DESIGNER. NO PORTION MAY BE REPRODUCED WITHOUT THE WRITTEN PERMISSION OF THE DESIGNERS

1. ALL DIMENSIONS ARE INCLUDING FINISHES
2. DO NOT SCALE DRAWING ONLY MENTIONED DIMENSIONS ARE TO BE CONSIDERED.
3. ALL DIMENSIONS MUST BE CHECKED BEFORE COMMENCING WORK ON SITE.
4. ANY DISCREPANCIES SHALL BE BROUGHT UNDER THE NOTICE OF ARCHITECTS PRIOR COMMENCEMENT OF WORK.

OTHER STORE

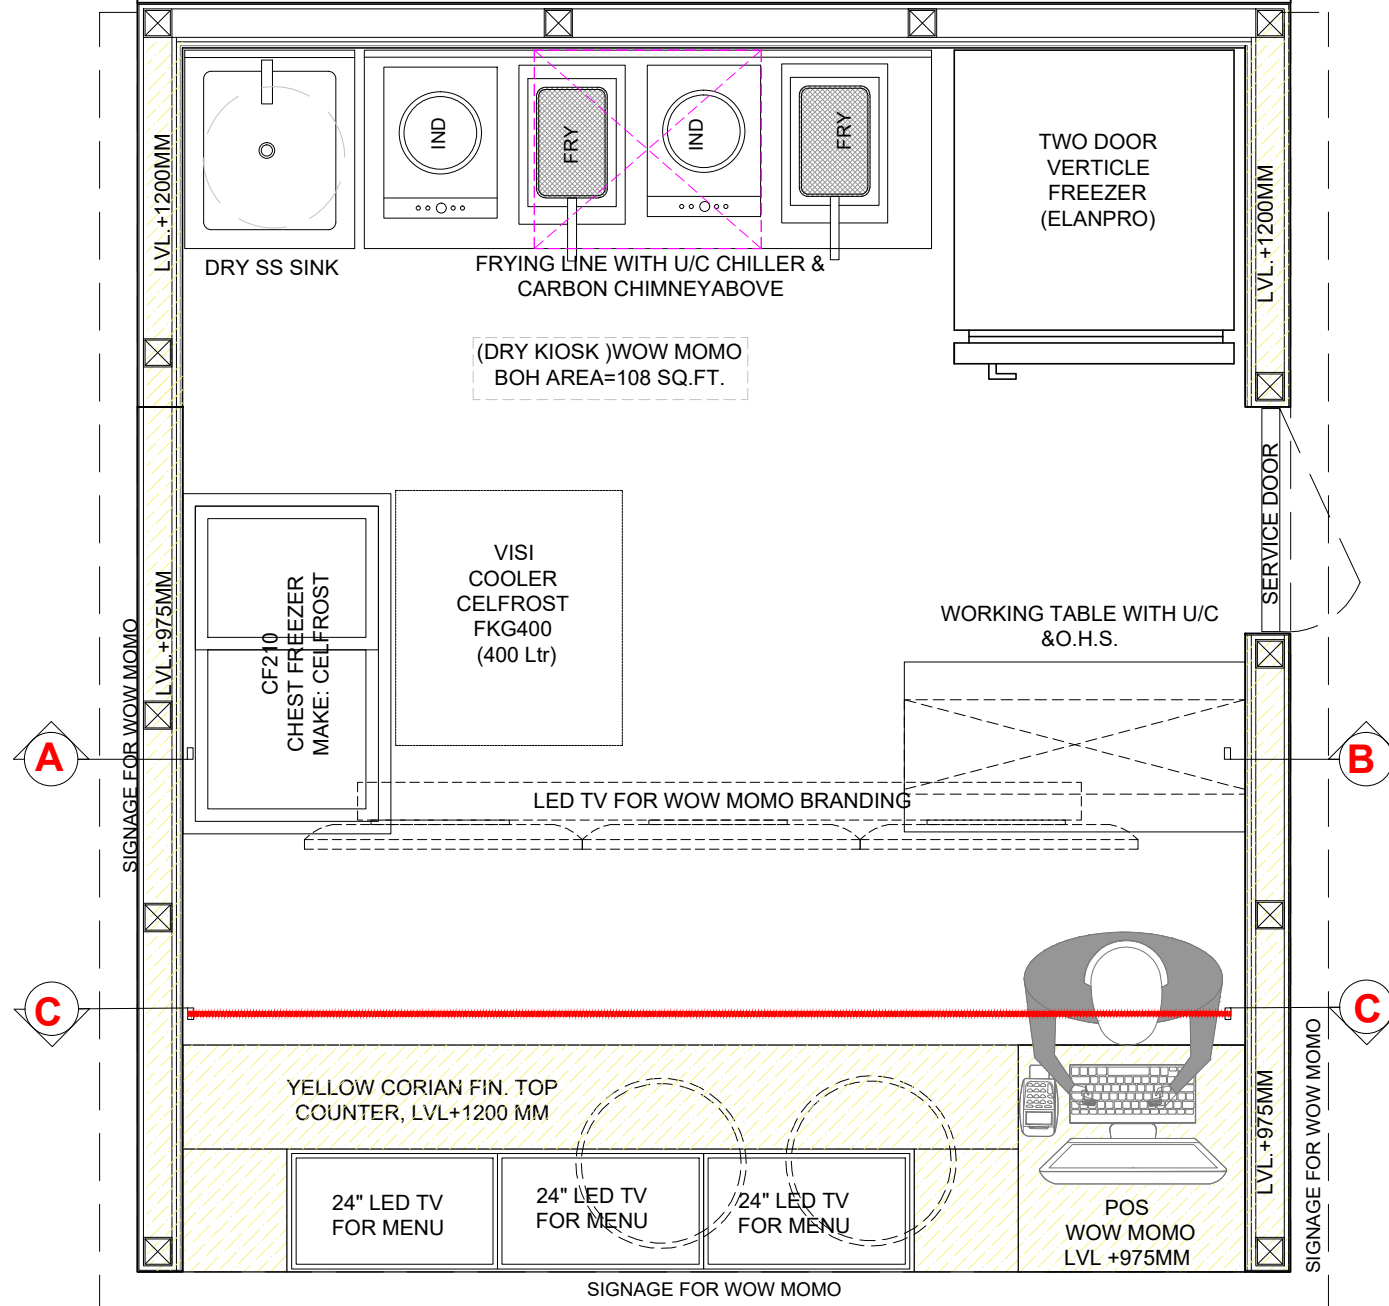

REVISION

S.NO.	REMARKS	DATE
1	REV 1	00/00/00
2	REV 2	00/00/00
3	REV 3	00/00/00
4	REV 4	00/00/00
5	REV 5	00/00/00
6	REV 6	00/00/00
7	REV 7	00/00/00
8	REV 8	00/00/00

ARCHITECT / INTERIOR DESIGN



CONSULTANT

CONSULTANT

RELEASE FOR

INFORMATION | TENDER | CONSTRUCTION | AS BUILT

TITLE

SECTIONAL DEMARCATION LAYOUT


DATE	07-10-2024
SCALE	NTS.
DRAWN BY	PUSHPENDER
CHECKED BY	AR.MANISH
PRINTED BY	-----
DWG. NO.	IA-200

SECTIONAL DEMARCATION LAYOUT

PROJECT
WOW MOMO @ MUMBAI AIRPORT T-2.

CLIENT
 WOW! MOMO FOODS PVT. LTD.

NOTE:
 THIS DRAWING & DESIGN IS THE COPYRIGHT OF THE DESIGNER. NO PORTION MAY BE REPRODUCED WITHOUT THE WRITTEN PERMISSION OF THE DESIGNERS
 1. ALL DIMENSIONS ARE INCLUDING FINISHES
 2. DO NOT SCALE DRAWING ONLY MENTIONED DIMENSIONS ARE TO BE CONSIDERED.
 3. ALL DIMENSIONS MUST BE CHECKED BEFORE COMMENCING WORK ON SITE.
 4. ANY DISCREPANCIES SHALL BE BROUGHT UNDER THE NOTICE OF ARCHITECTS PRIOR COMMENCEMENT OF WORK.

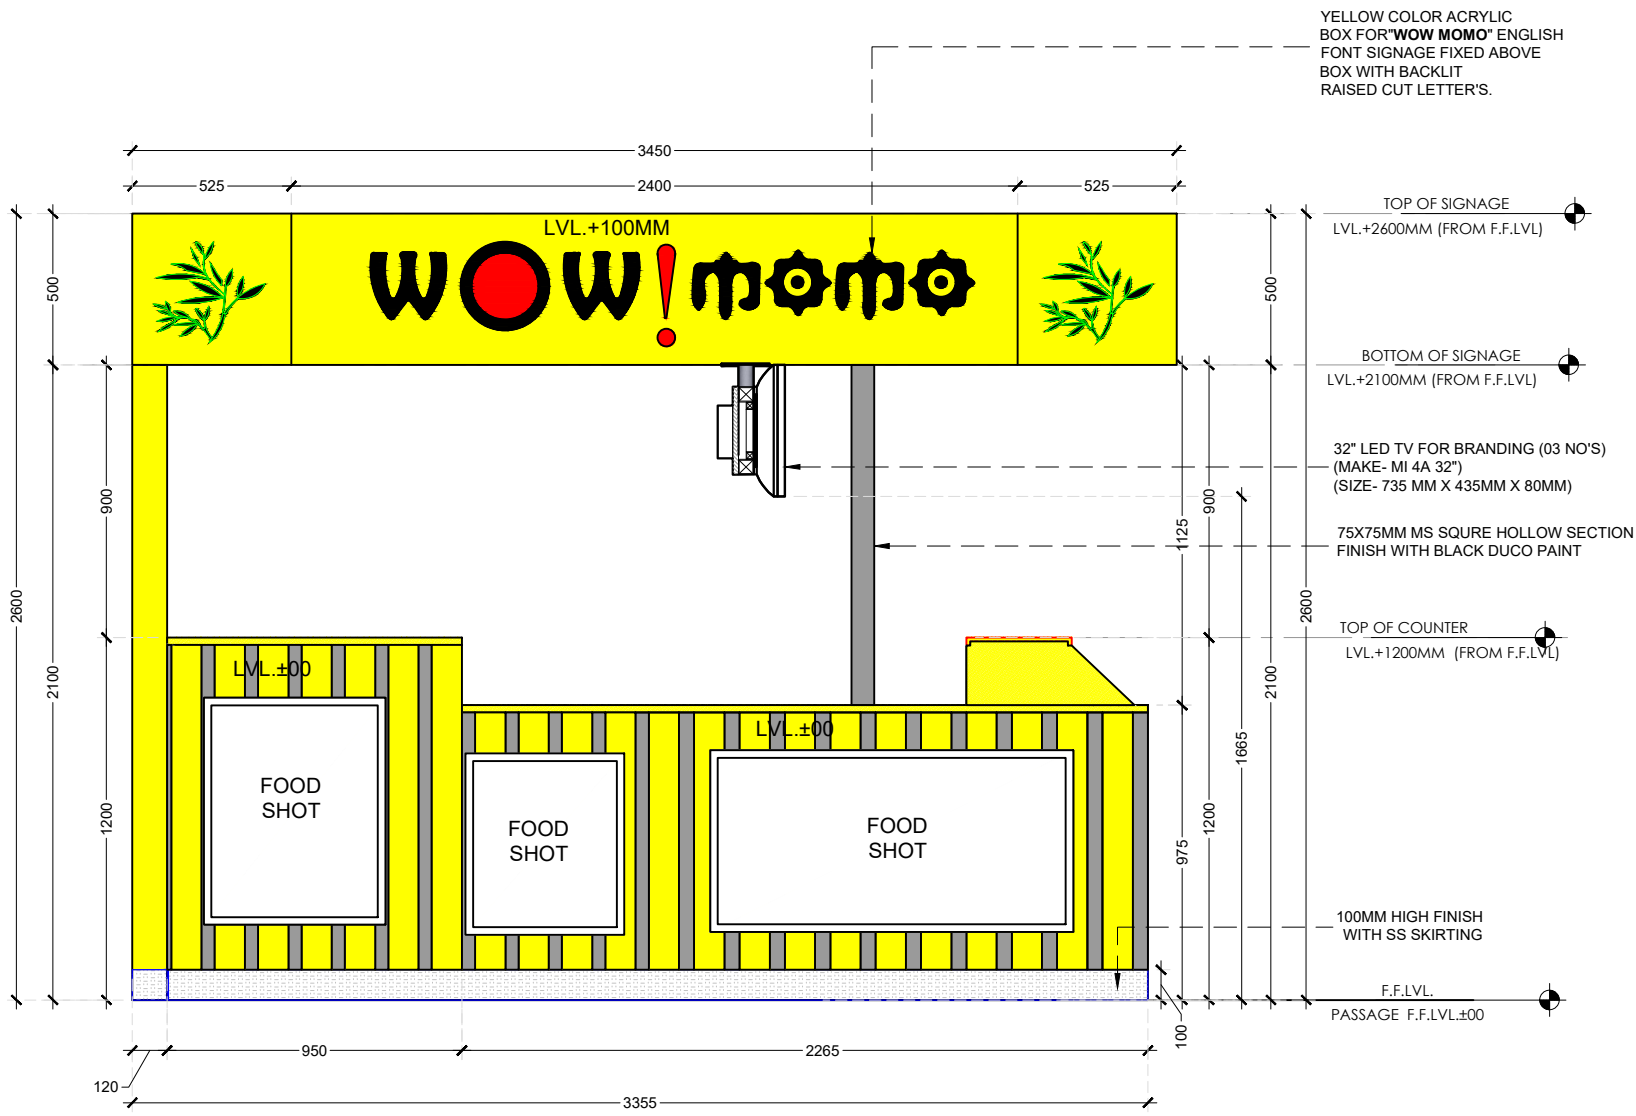

SECTIONAL ELEVATION AA

REVISION

S.NO.	REMARKS	DATE
1	REV 1	00/00/00
2	REV 2	00/00/00
3	REV 3	00/00/00
4	REV 4	00/00/00
5	REV 5	00/00/00
6	REV 6	00/00/00
7	REV 7	00/00/00
8	REV 8	00/00/00

ARCHITECT / INTERIOR DESIGN

ARCHITANK STUDIO
 ARCHITECTURE PLANNING
 INTERIOR FURNITURE
 FLAT NO-13 DDA SFS
 SLAT POCKET-1 SEC-6 DWARKA,
 NEW DELHI-110075
 EMAIL:-info@atankstudio@gmail.com
 OFF-011-35559249, MOB.9910315171


CONSULTANT

CONSULTANT

RELEASE FOR
 INFORMATION | TENDER | CONSTRUCTION | AS BUILT

TITLE
 ELEVATIONS

DATE	07-10-2024
SCALE	NTS.
DRAWN BY	PUSHPENDER
CHECKED BY	AR MANISH
PRINTED BY	-----
DWG. NO.	IA-201

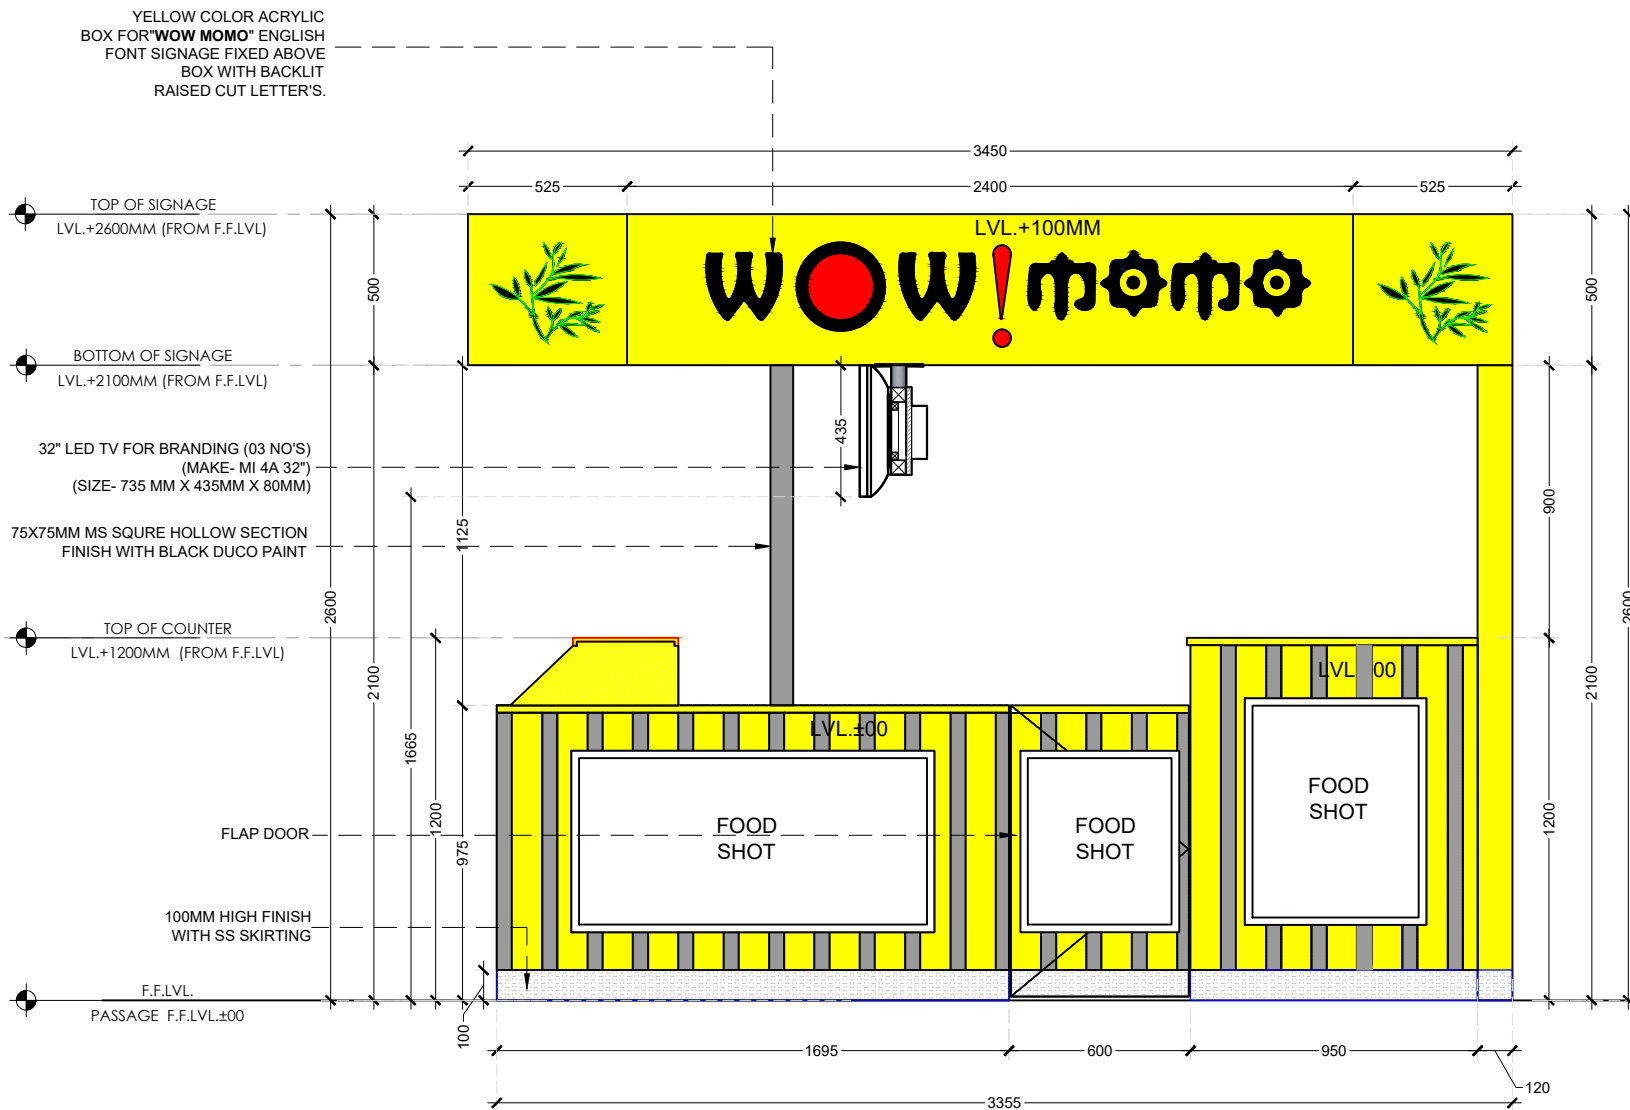


SECTIONAL ELEVATION BB

PROJECT
WOW MOMO @ MUMBAI AIRPORT T-2.

CLIENT
 WOW! MOMO FOODS PVT. LTD.

NOTE:
 THIS DRAWING & DESIGN IS THE COPYRIGHT OF THE DESIGNER. NO PORTION MAY BE REPRODUCED WITHOUT THE WRITTEN PERMISSION OF THE DESIGNERS
 1. ALL DIMENSIONS ARE INCLUDING FINISHES
 2. DO NOT SCALE DRAWING. ONLY MENTIONED DIMENSIONS ARE TO BE CONSIDERED.
 3. ALL DIMENSIONS MUST BE CHECKED BEFORE COMMENCING WORK ON SITE.
 4. ANY DISCREPANCIES SHALL BE BROUGHT UNDER THE NOTICE OF ARCHITECTS PRIOR COMMENCEMENT OF WORK.

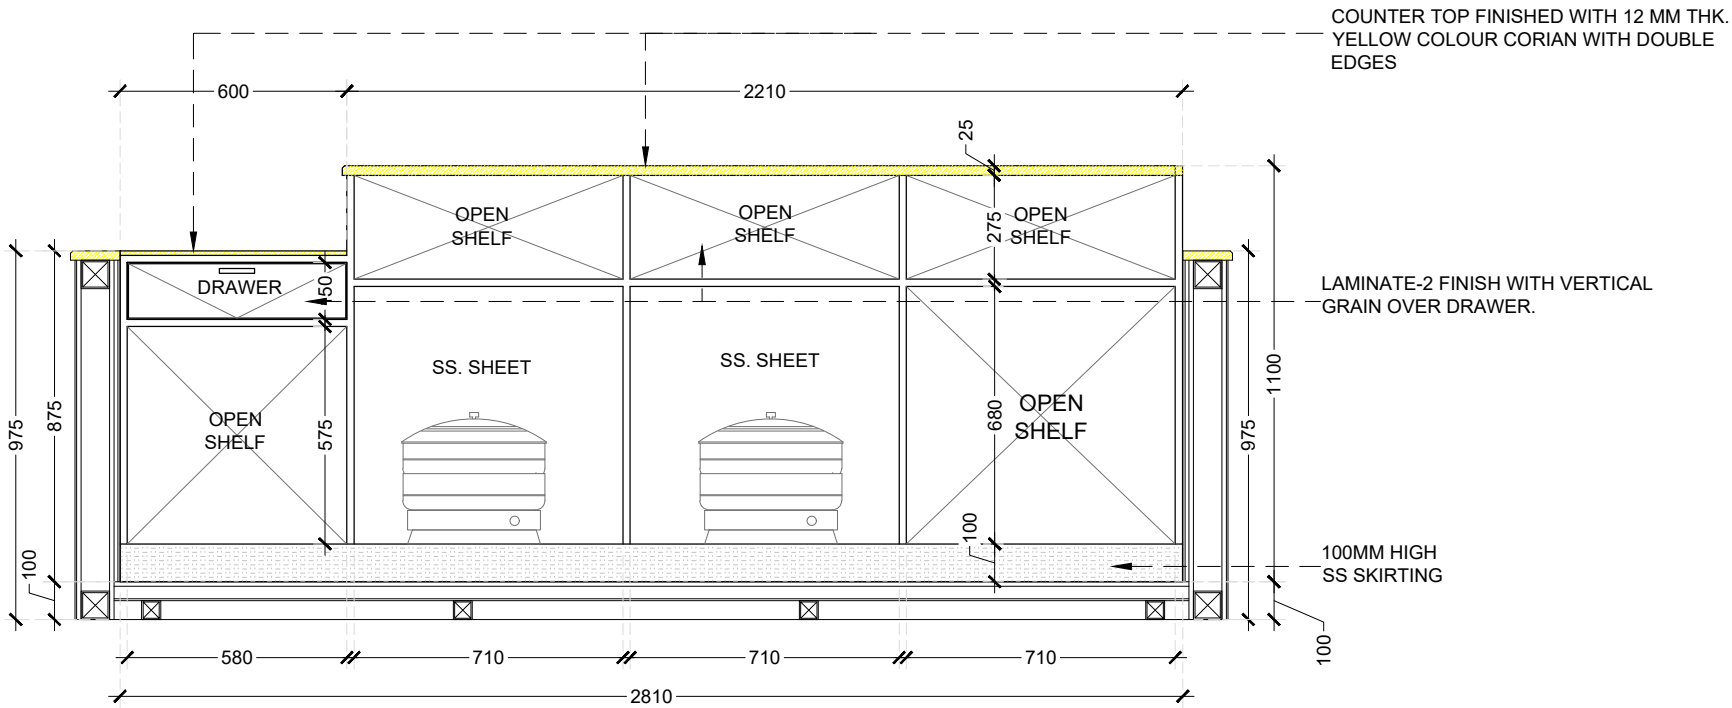

SECTIONAL ELEVATION CC

REVISION

S.NO.	REMARKS	DATE
1	REV 1	00/00/00
2	REV 2	00/00/00
3	REV 3	00/00/00
4	REV 4	00/00/00
5	REV 5	00/00/00
6	REV 6	00/00/00
7	REV 7	00/00/00
8	REV 8	00/00/00

ARCHITECT / INTERIOR DESIGN

AS ARCHITECTURE PLANNING INTERIOR FURNITURE
 FLAT NO-13 DDA SFS
 SLAT POCKET-1 SEC-6 DWARKA,
 NEW DELHI-110075
 EMAIL- info@alts@gmail.com
 OFF-011-35559249 MOB-9810315171

CONSULTANT


CONSULTANT

RELEASE FOR

INFORMATION	TENDER	CONSTRUCTION	AS BUILT


TITLE
 ELEVATIONS

DATE	07-10-2024
SCALE	NTS.
DRAWN BY	PUSHPENDER
CHECKED BY	AR.MANISH
PRINTED BY	-----
DWG. NO.	IA-202

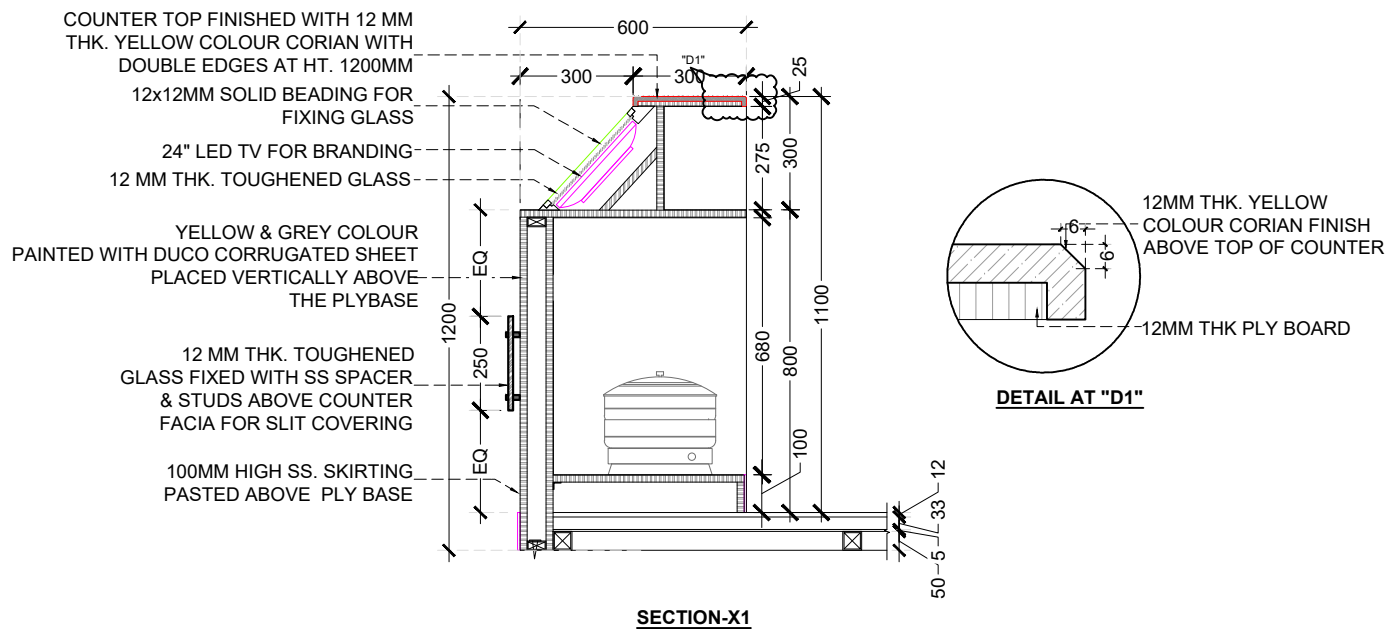

COUNTER TYPICAL DETAIL

V:\WOW MOMO\MAHABHADRAN\MUMBAI AIRPORT T-2\DRAWINGS\PROPOSED LAYOUT.dwg, 08-10-2024 12:56:54, DWG TO PDF.PLT

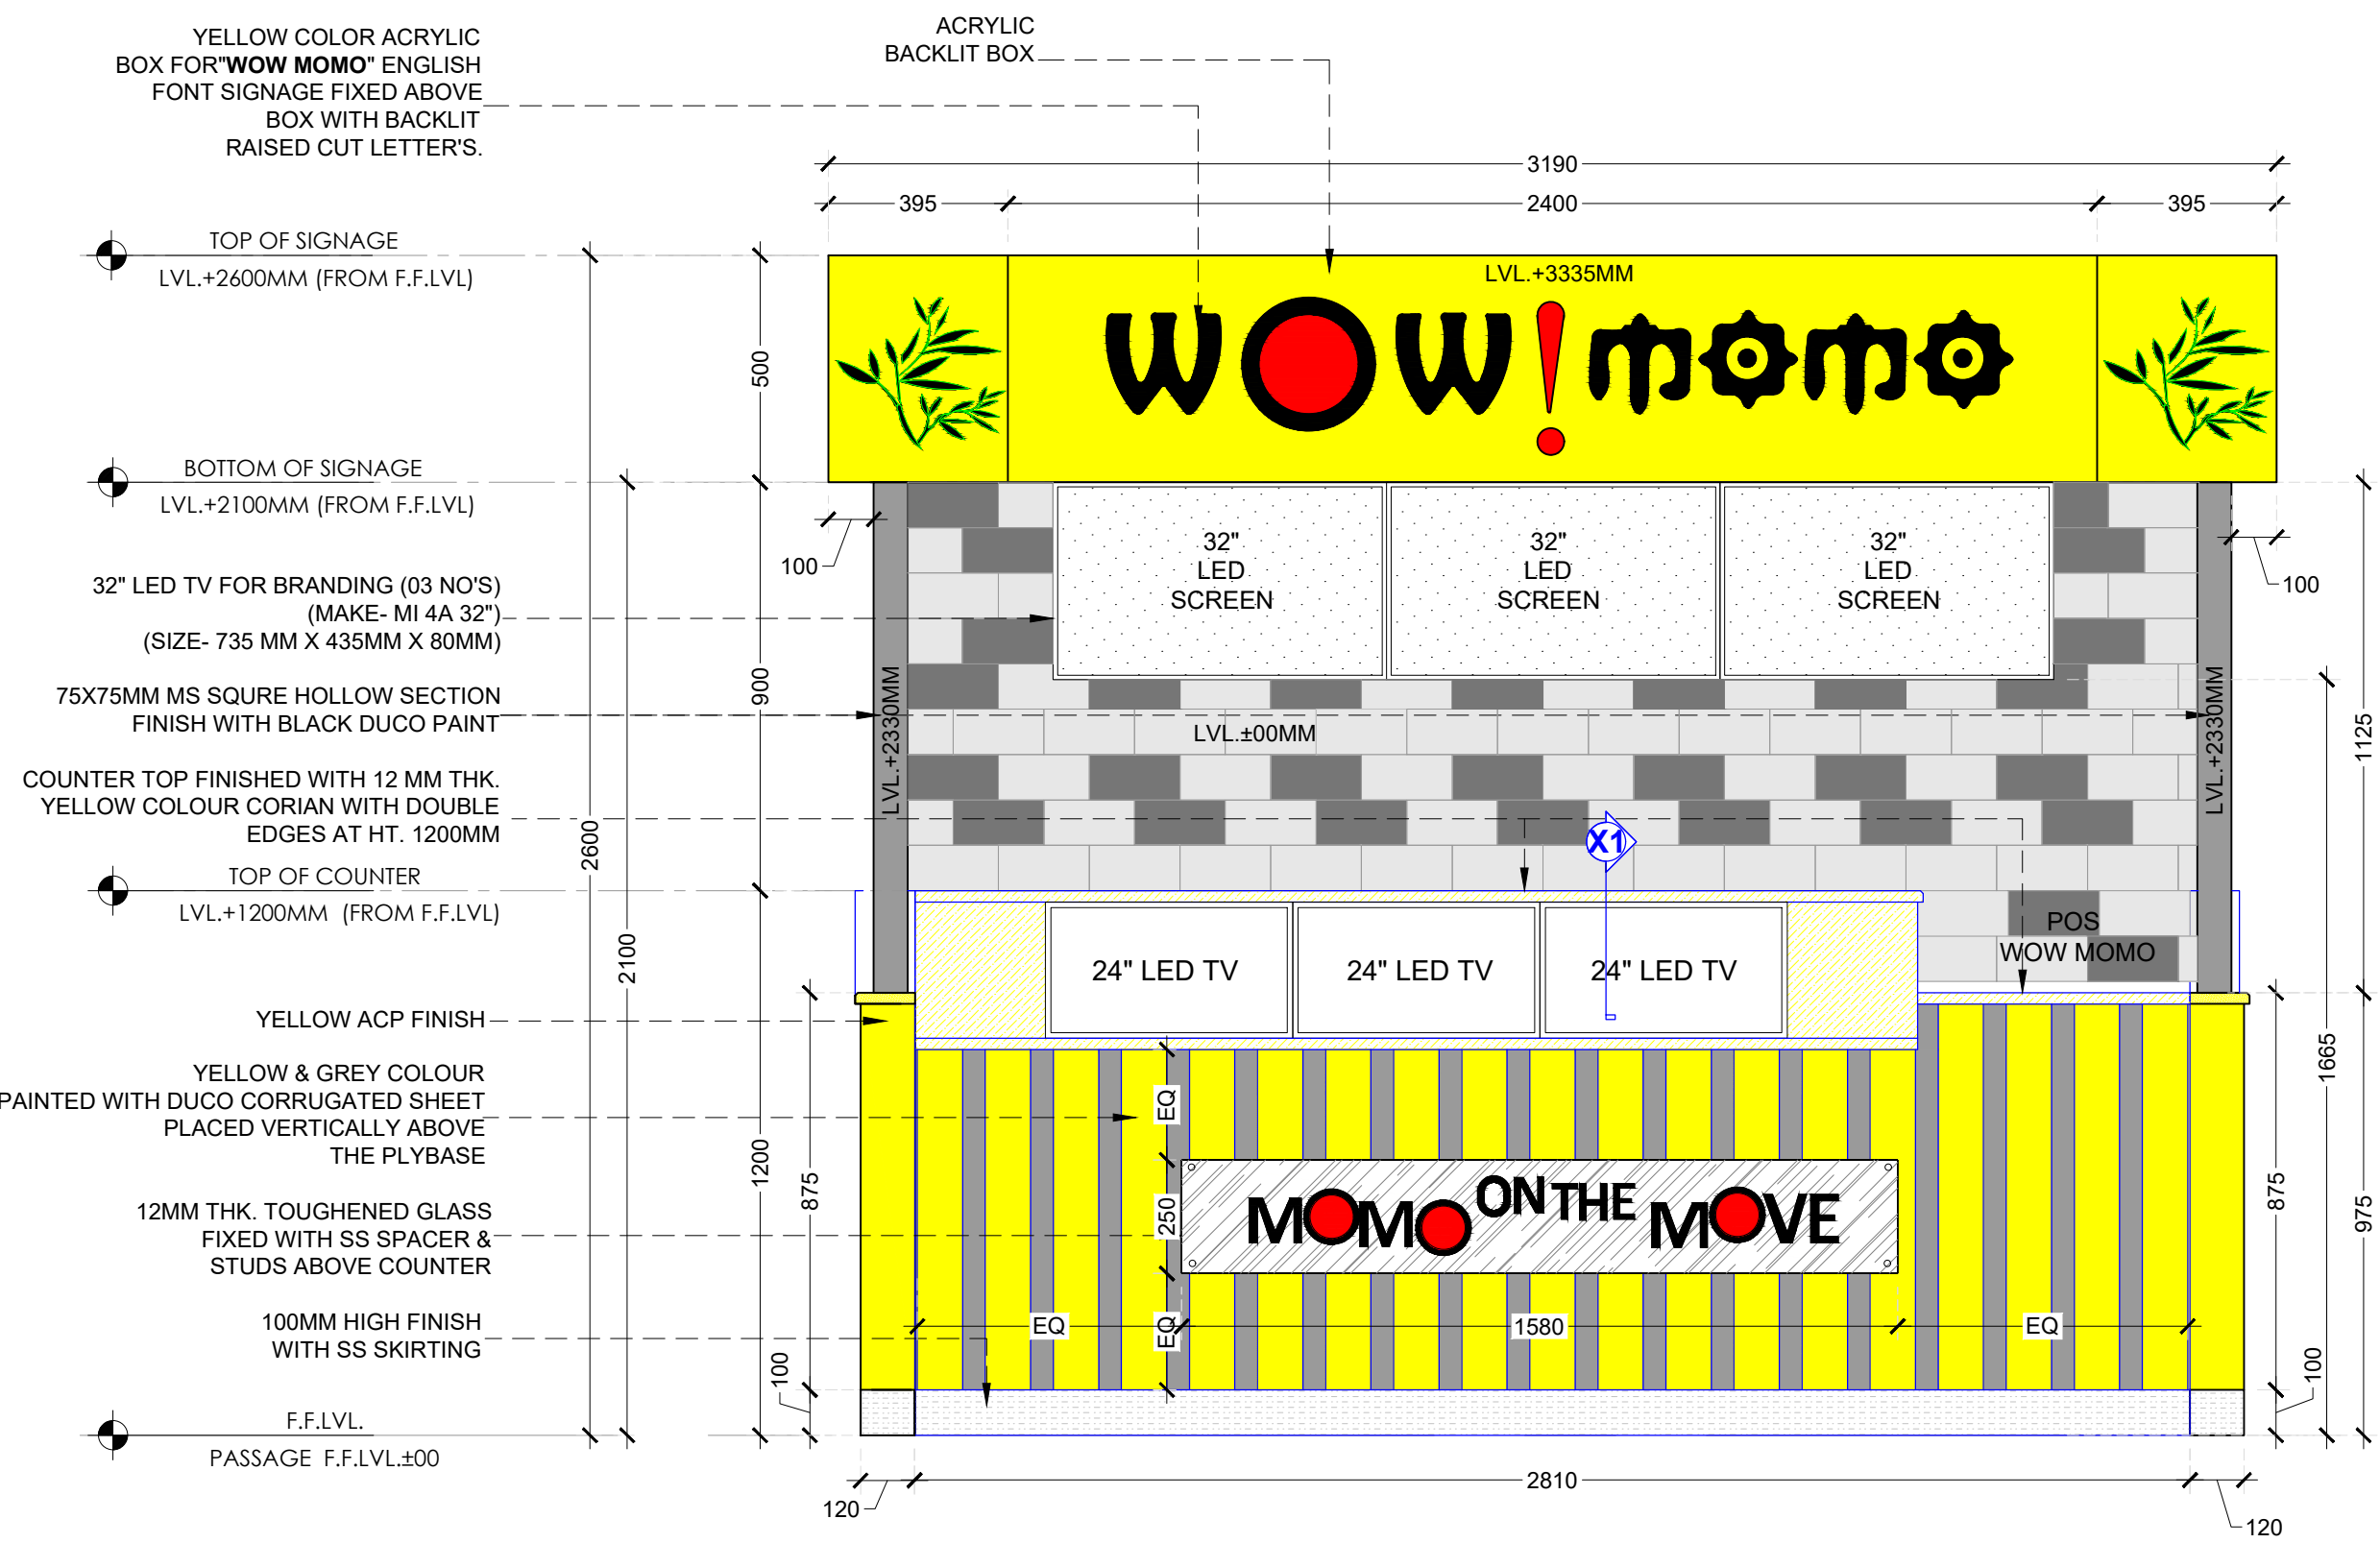

FRONT ELEVATION

PROJECT
WOW MOMO @ MUMBAI AIRPORT T-2.
CLIENT
WOW MOMO FOODS PVT. LTD.

NOTE:
 THIS DRAWING & DESIGN IS THE COPYRIGHT OF THE DESIGNER. NO PORTION MAY BE REPRODUCED WITHOUT THE WRITTEN PERMISSION OF THE DESIGNERS
 1. ALL DIMENSIONS ARE INCLUDING FINISHES
 2. DO NOT SCALE DRAWING. ONLY MENTIONED DIMENSIONS ARE TO BE CONSIDERED.
 3. ALL DIMENSIONS MUST BE CHECKED BEFORE COMMENCING WORK ON SITE.
 4. ANY DISCREPANCIES SHALL BE BROUGHT UNDER THE NOTICE OF ARCHITECTS PRIOR COMMENCEMENT OF WORK.

REVISION		
S.NO.	REMARKS	DATE
1	REV 1	00/00/00
2	REV 2	00/00/00
3	REV 3	00/00/00
4	REV 4	00/00/00
5	REV 5	00/00/00
6	REV 6	00/00/00
7	REV 7	00/00/00
8	REV 8	00/00/00

ARCHITECT / INTERIOR DESIGN

ds ARCHITECTURE & INTERIOR DESIGN STUDIO

FLAT NO-197, DDA SFS
 FLAT POCKET -1 SEC-6 DWARKA,
 NEW DELHI-110075
 EMAIL:-infoatats@gmail.com
 OFF-011-40314174, MOB:9910315171

CONSULTANT

CONSULTANT

RELEASE FOR			
INFORMATION	TENDER	CONSTRUCTION	AS BUILT

TITLE			
FRONT ELEVATION			
DATE	07-10-2024	CHECKED BY	AR.MANISH
SCALE	N.T.S.	PRINTED BY	_____
DWG. NO.	IA-203	DRAWN BY	PUSHPENDER