


1) DO NOT SCALE THE DRAWINGS FOLLOW THE WRITTEN DIMENSIONS.
 2) ALL THE DIMENSIONS SHOWN ARE IN ENGLISH UNITS.
 3) ALL THE MATERIALS FOR CONSTRUCTION SHALL BE TO 'IS' STANDARDS AND AS PER THE SPECIFICATIONS BY THE ARCHITECT.
 4) ANY AMBIGUITY FOUND IN THE DRAWING SHALL BE IMMEDIATELY BROUGHT TO THE NOTICE OF AN ARCHITECT.

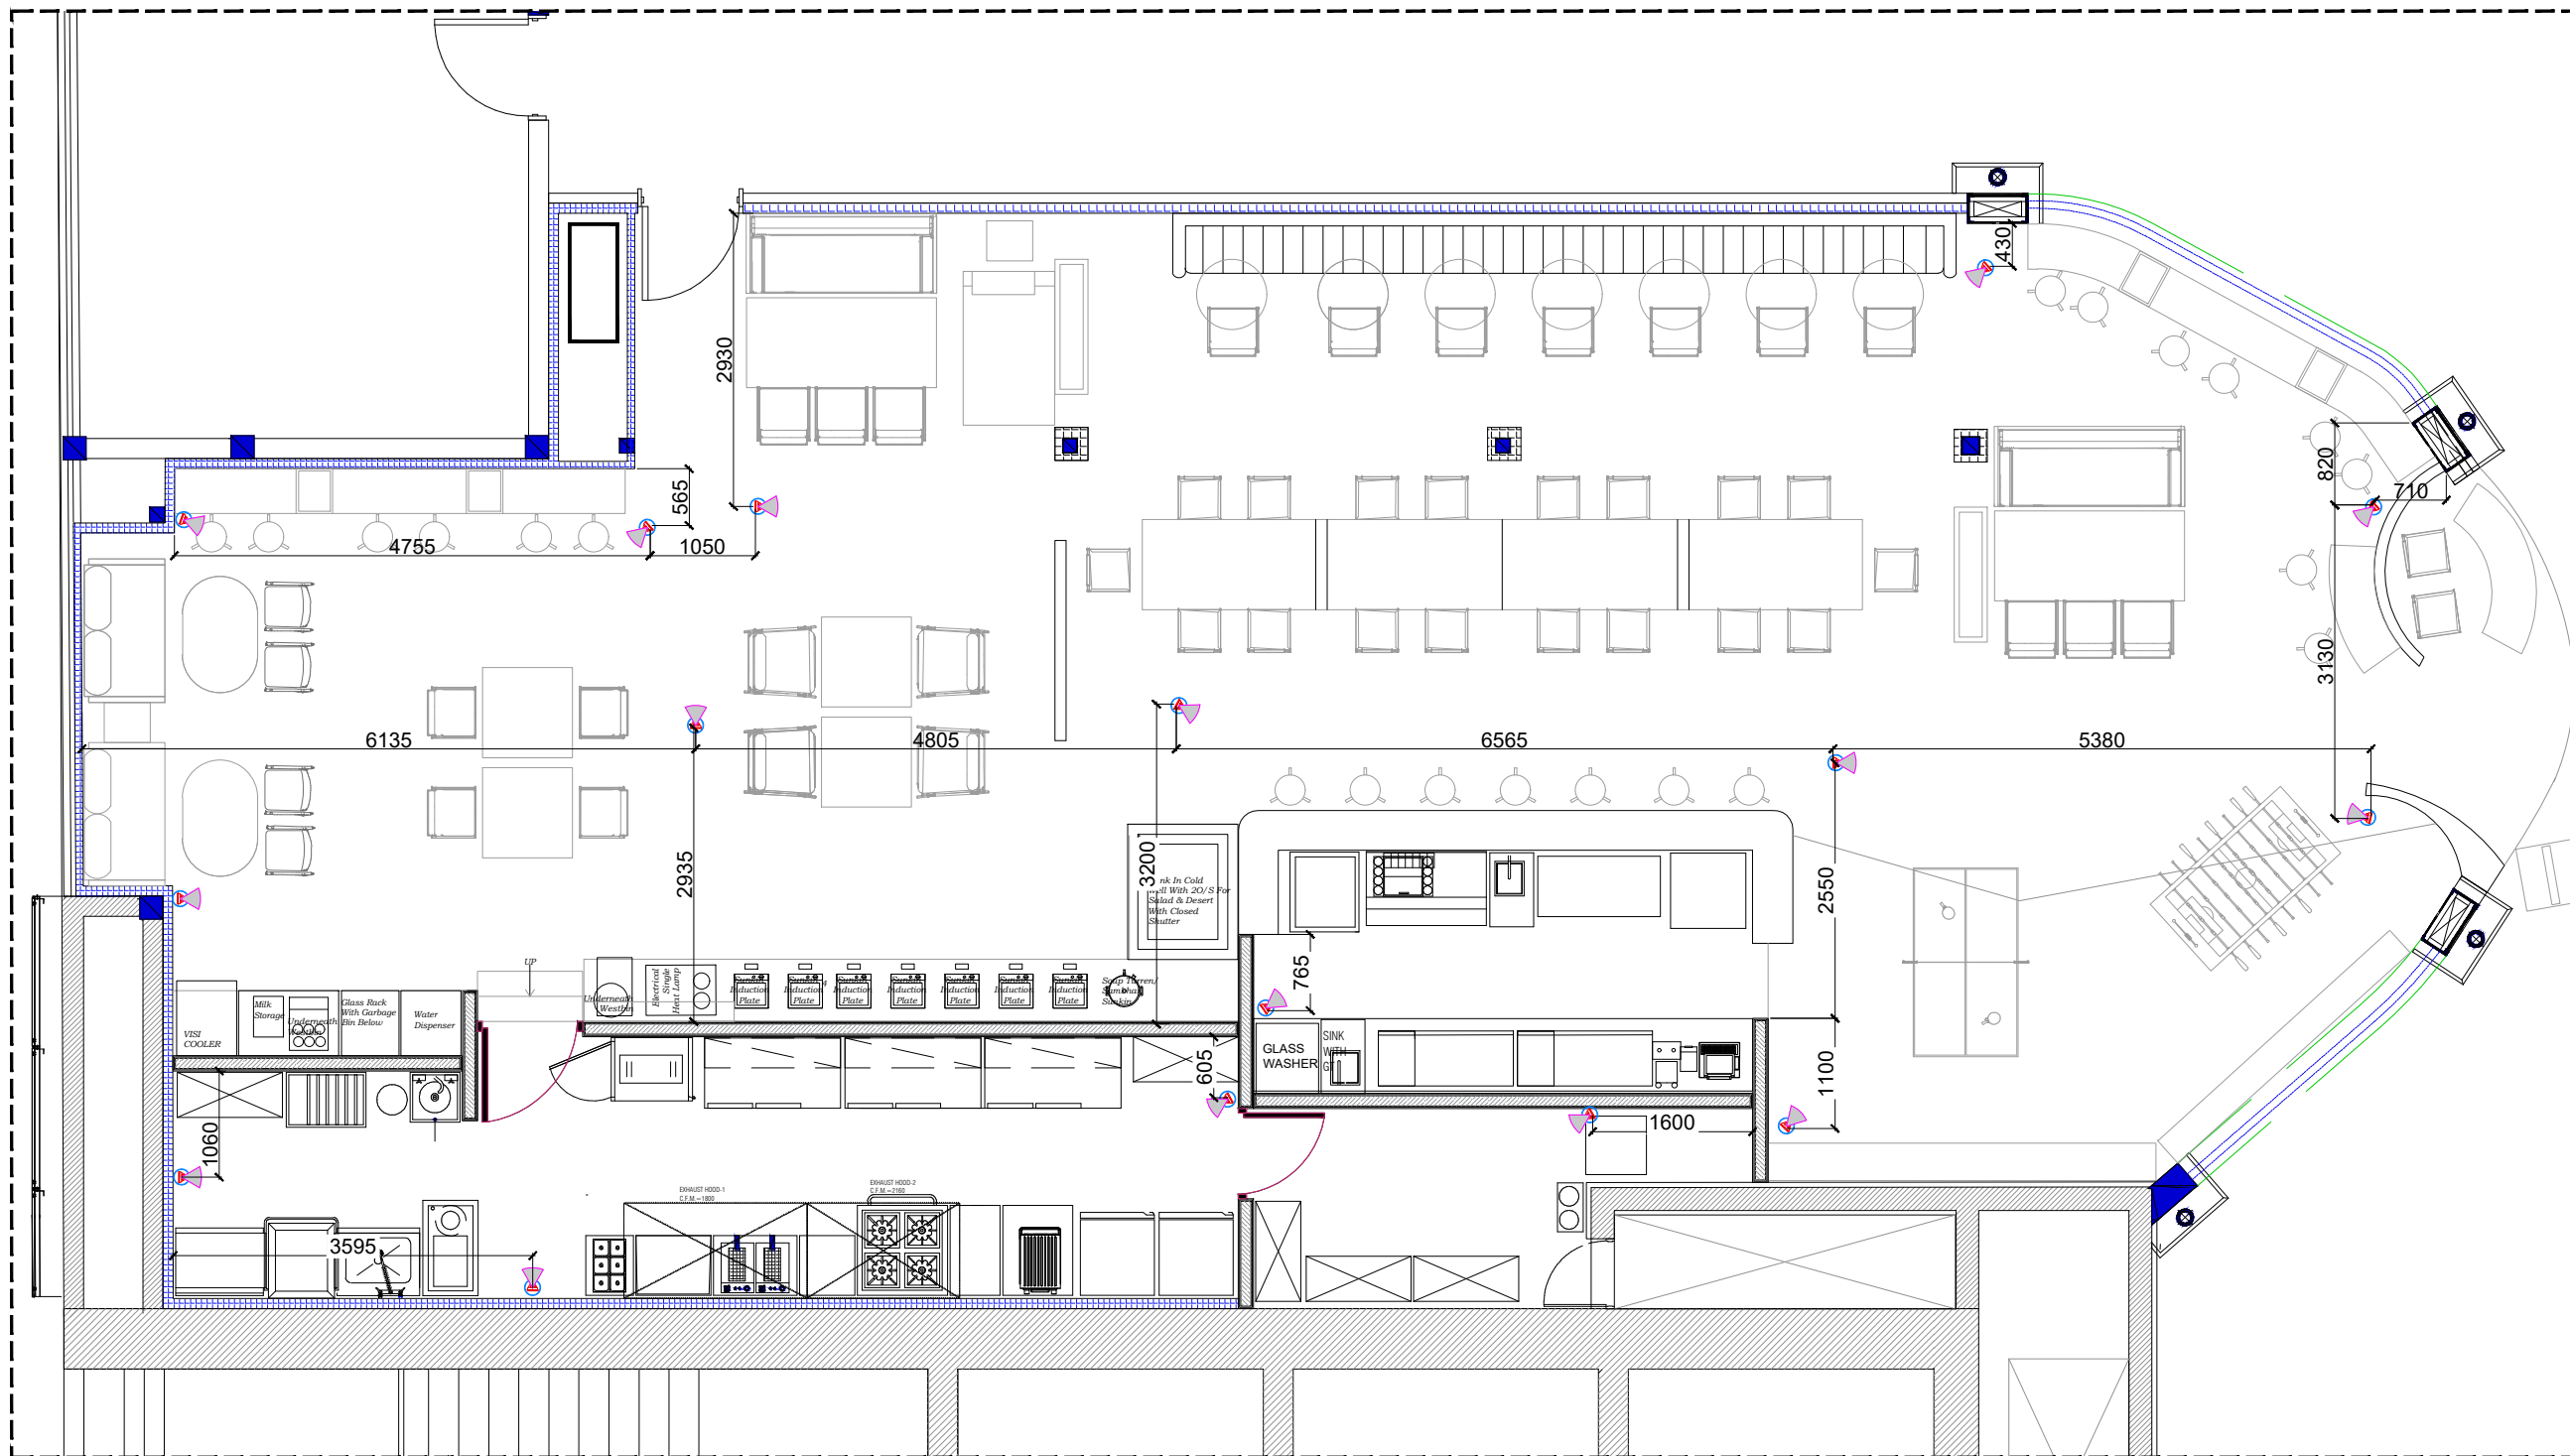

REVISIONS	
DESCRIPTION	DATE
	YYYY-MM-DD
	YYYY-MM-DD
	YYYY-MM-DD

SIGN/STAMP

AIRPORT NAME
 LUCKNOW AIRPORT TERMINAL 3

LOCATION
 DOMESTIC SHA

BRAND NAME / PROJECT NAME
 BUDWEISER

DRAWING TYPE
 GFC

CCTV LAYOUT & WORKING

DRN BY	MR	SCALE	1:75	R0
CHKD BY	AP	REV		
DATE	2024-02-07			
DWG NO. TFS_LK0_DSHA_BD_GFC-B-102				
ARCHITECT: Genesis Architects Pvt. Ltd.				

SHIV SAGAR ESTATE
 A - BLOCK, 1ST FLOOR
 ANNIE BESANT ROAD,
 WORLI, MUMBAI 400018.
 PH: +91 (22) 4322 4322

1 **CCTV LAYOUT & WORKING**
 Scale:-1:75

CCTV SYSTEM LEGEND			
S.NO	DESCRIPTION	NOS	LEGEND
1	Ceiling mounted dome camera	16	
2	TFT 15" High resolution monitor with power supply.	01	
3	SITC of power supply & DVR	01	