




TRAVEL FOOD SERVICES

STATUS OF RELEASE:	
<input type="checkbox"/> FOR APPROVAL	<input type="checkbox"/> FOR TENDER
<input type="checkbox"/> FOR DISCUSSION	<input checked="" type="checkbox"/> FOR CONSTRUCTION
REV.	DATE
PREP BY	CHK BY
APPROV BY	REMARK

STAMP:	
PROJECT NAME:	BIKANERVALLA@EKLERA
CLIENT NAME:	BIKANERVALLA@EKLERA
ARCHITECT:	TFS
DRAWING NO.:	BK-CCTV-01-RO
SCALE:	
DATE:	24-04-2024
PREP:	NIROU SHRIVALL
CHKD:	DHEERAJ YADAV
APPVD:	RITUPARN SHARMA

Bikanervala CCTV Layout

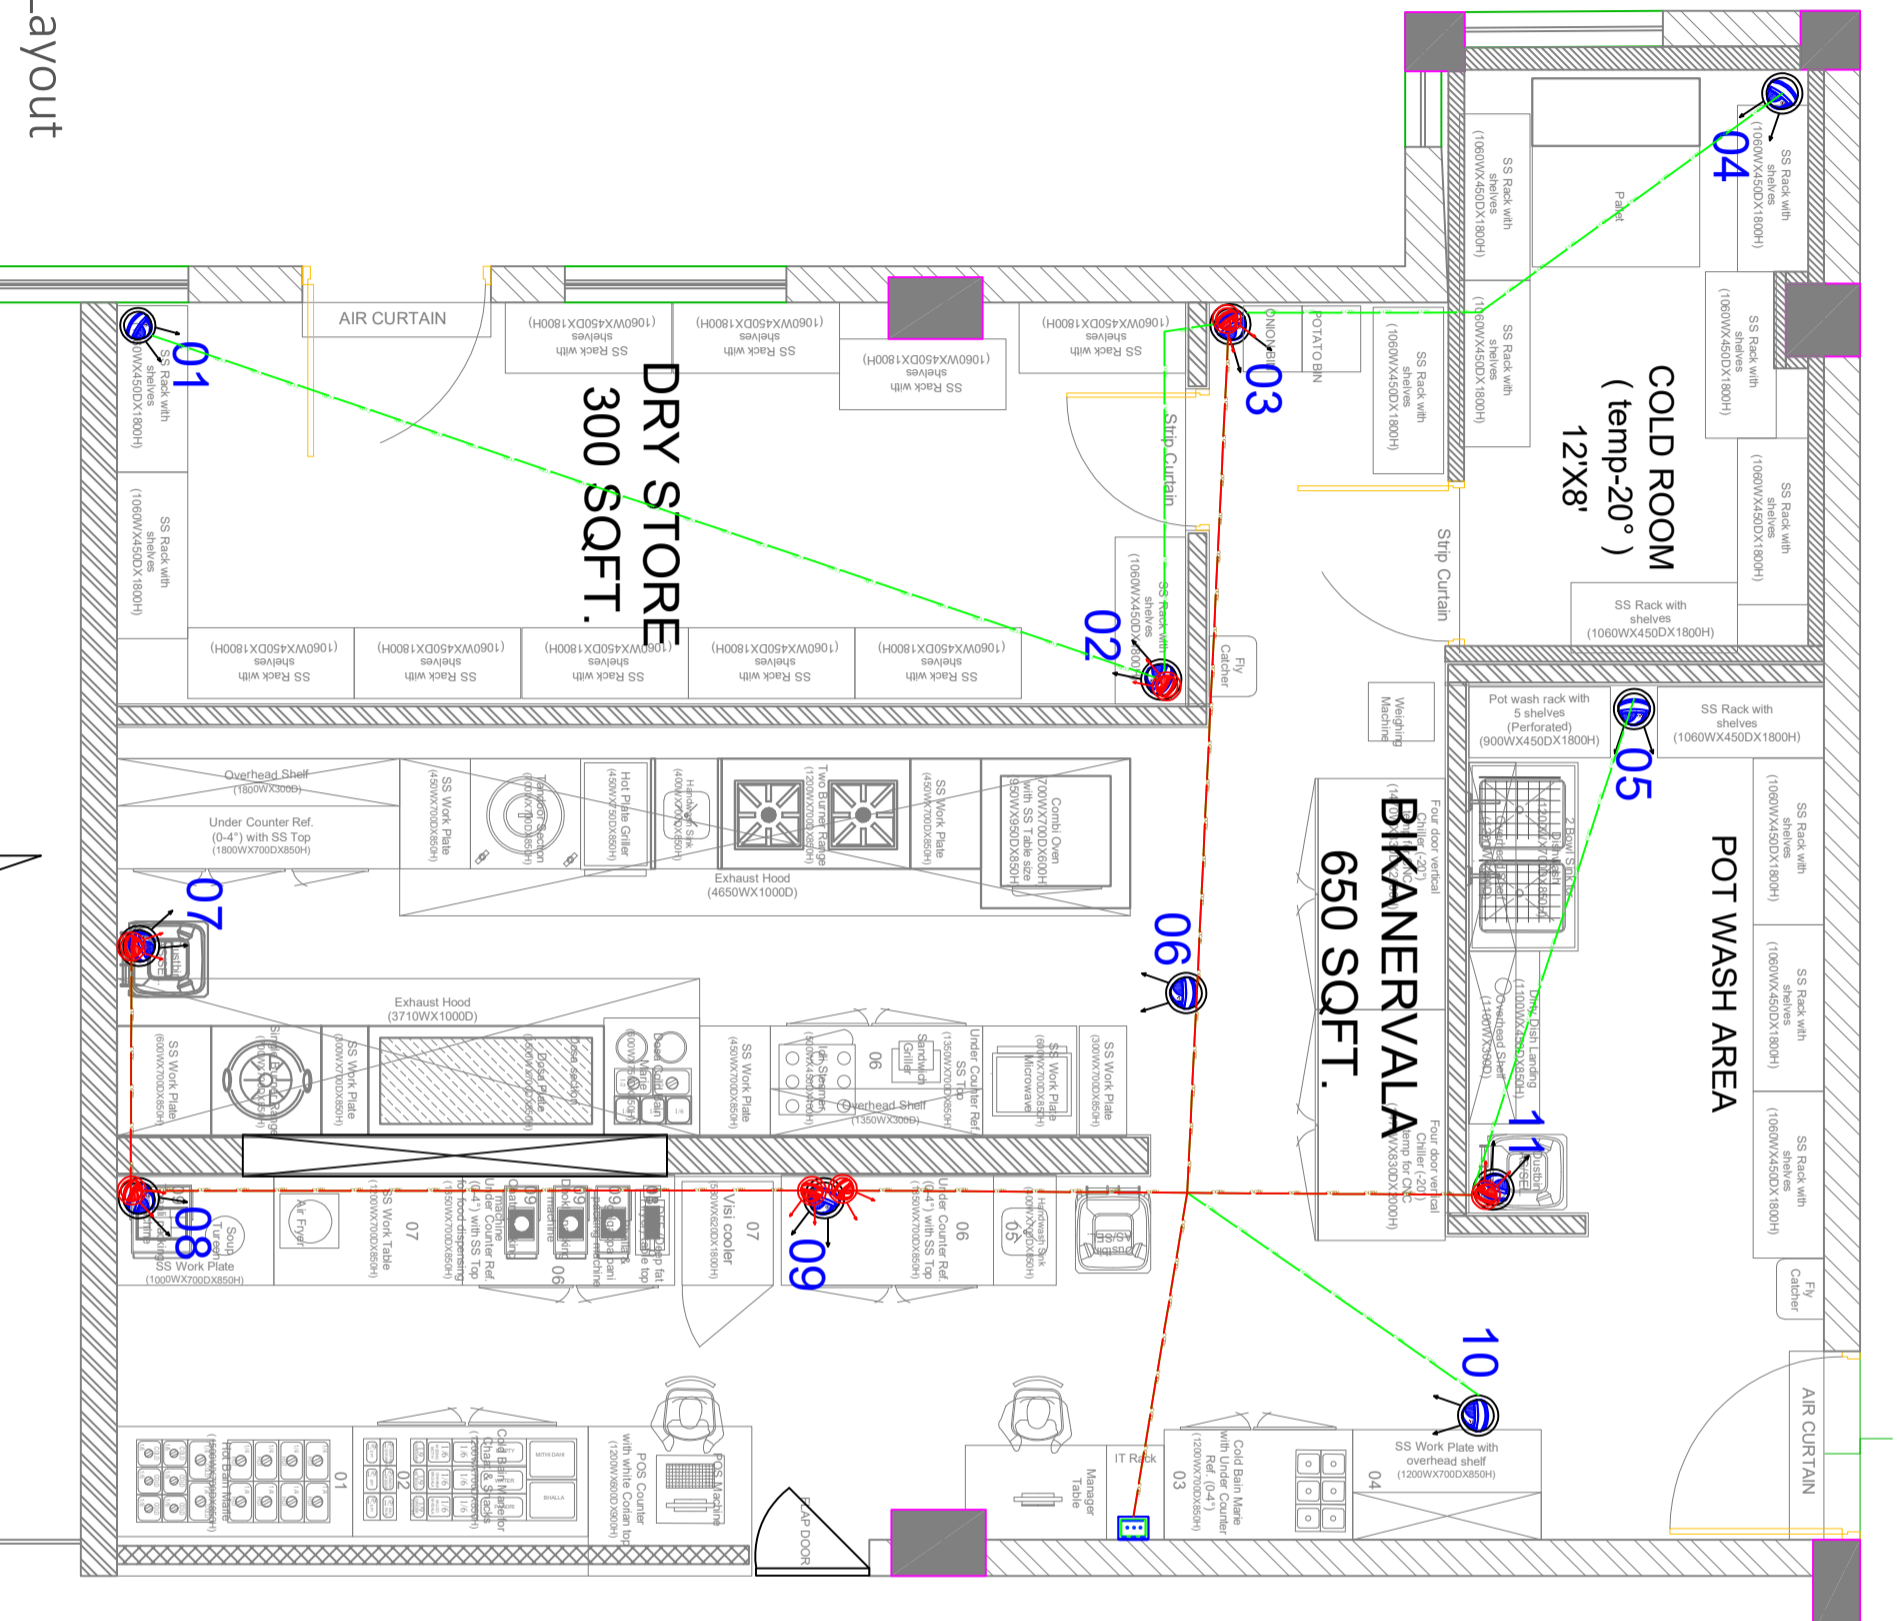

LEGENDS:

Mounting Height	Symbol	Item Description
IN CEILING		CAT6 IN 25mm Rigid PVC Conduit for CCTV
WITH THE IT RACK		4" NETWORK RACK
CEILING		CCTV CAMERA total 11 NOS.