

CODE	DESCRIPTION
C01	CHILLER
C02	SCOOP
C03	CASH COUNTER IN PLY
C04	STONE
C05	FRIDGE
C06	SINK 350X350
C07	BIN
C08	MOVEBLE JANITOR IN PLY

NOTE

1. All dimensions are in mm, unless specified.
2. Do not scale this drawing, only written dimensions need to be followed.
3. Any discrepancy in the drawing, to be brought to the notice of Architect.

The copy rights of this document is with SAMRAT ASSOCIATES, and it shouldn't be used by anybody without the written permission of Architect.

CLIENT:

M/S CREAM STONE

PROJECT/LOCATION:

CREAM STONE, DSHA @HYD AIRPORT



TITLE:

FLOOR PLAN

DRAWN: BUSHRA

DATE: 08-04-2024

SCALE : NOT TO SCALE

ARCHITECTS

SAMRAT ASSOCIATES


Architecture | Interiors | Project Management

Khajaguda, Prashant Hills

Hyderabad,

040-23311009

E mail: samratarchitects@gmail.com

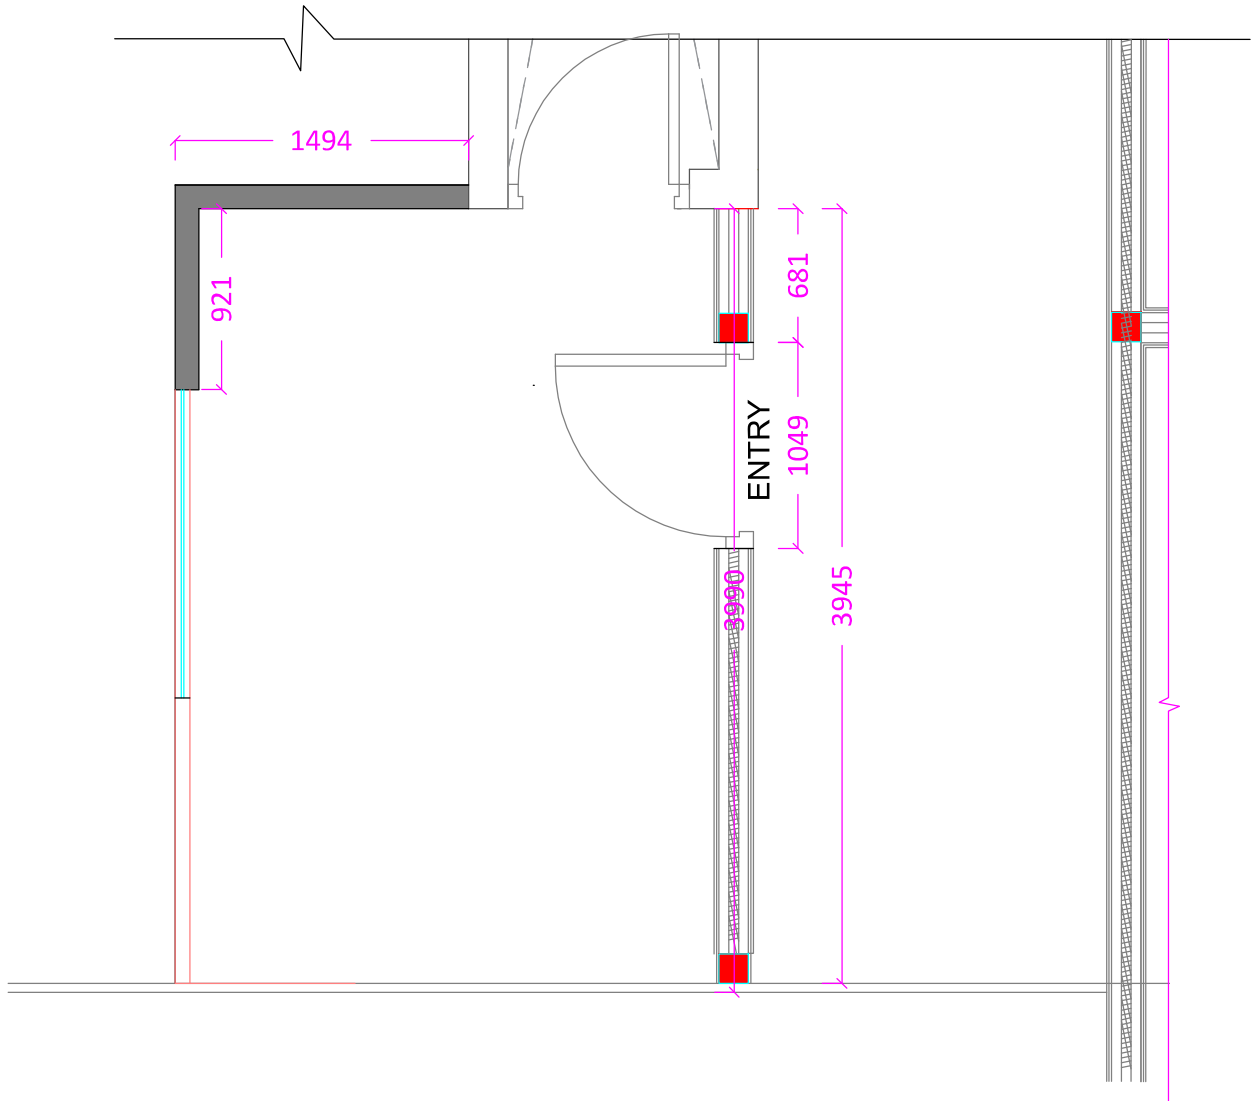

NOTE

1. All dimensions are in mm, unless specified.
2. Do not scale this drawing, only written dimensions need to be followed.
3. Any discrepancy in the drawing, to be brought to the notice of Architect.

 
The copy rights of this document is with SAMRAT ASSOCIATES, and it shouldn't be used by anybody without the written permission of Architect.

CLIENT:

M/S CREAM STONE

PROJECT/LOCATION:

CREAM STONE, DSHA
@HYD AIRPORT



TITLE:

CIVIL PLAN

DRAWN: BUSHRA

DATE: 08-04-2024

SCALE : NOT TO SCALE

ARCHITECTS

SAMRAT ASSOCIATES


Architecture | Interiors | Project Management

Khajaguda, Prashant Hills

Hyderabad,

040-23311009

E mail: samratarchitects@gmail.com

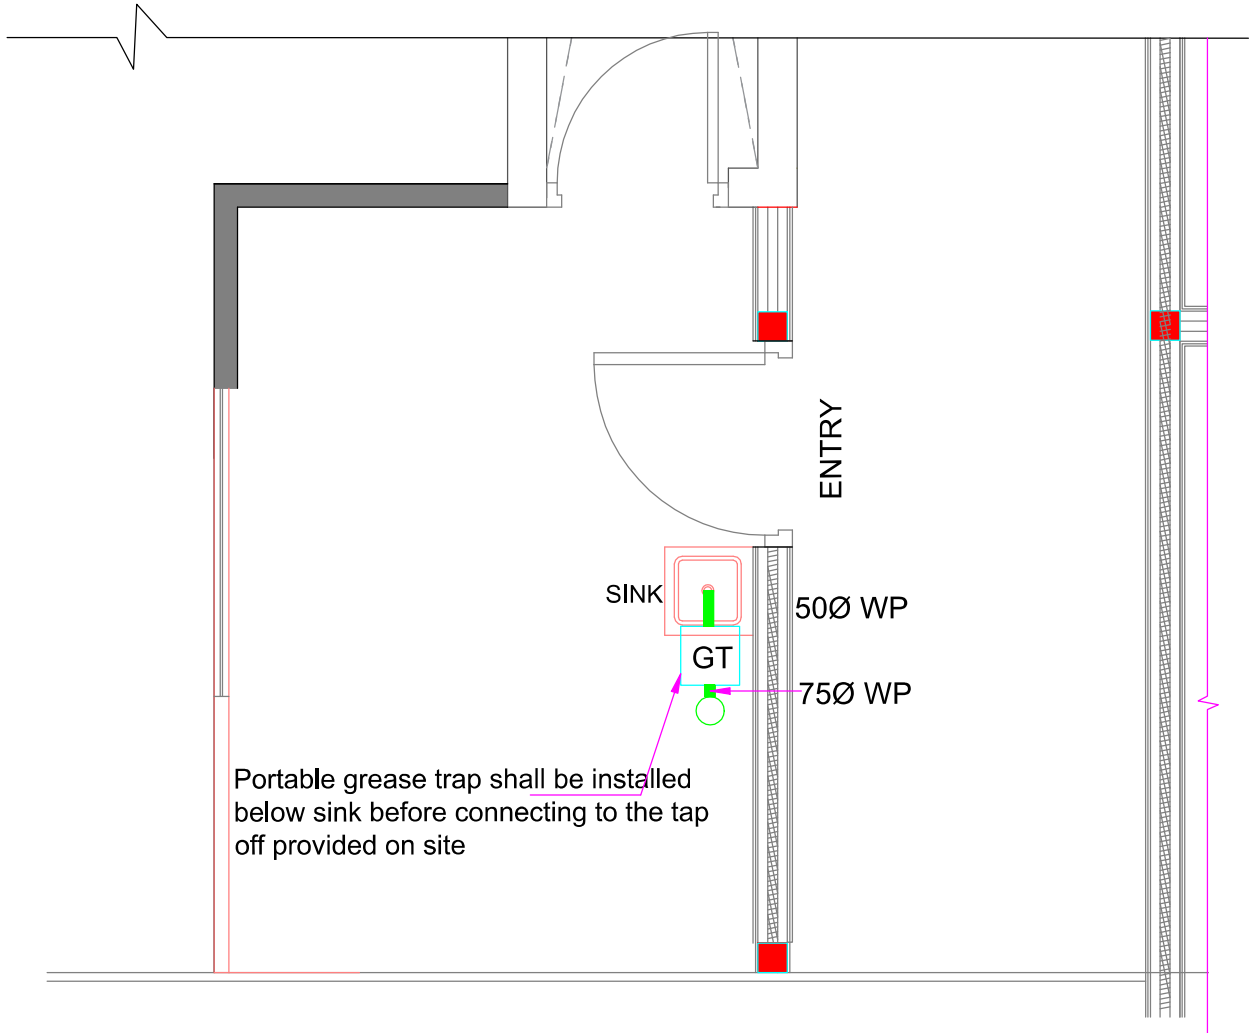

PHE LEGEND	
	WASTE PIPE (WP)
	DOMESTIC WATER SUPPLY (DWS)
	HOT WATER SUPPLY (HWS)
	FLOOR TRAP (FT)
GT	GREASE TRAP

NOTE

1. All dimensions are in mm, unless specified.
2. Do not scale this drawing, only written dimensions need to be followed.
3. Any discrepancy in the drawing, to be brought to the notice of Architect.

 
The copy rights of this document is with SAMRAT ASSOCIATES, and it shouldn't be used by anybody without the written permission of Architect.

CLIENT:

M/S CREAM STONE

PROJECT/LOCATION:

CREAM STONE, DSHA @HYD AIRPORT



TITLE:

DRAINAGE LAYOUT

DRAWN: RACHANA

DATE: 07-03-2024

SCALE : NOT TO SCALE

ARCHITECTS

SAMRAT ASSOCIATES


Architecture | Interiors | Project Management

Khajaguda, Prashant Hills

Hyderabad,

040-23311009

E mail: samratarchitects@gmail.com

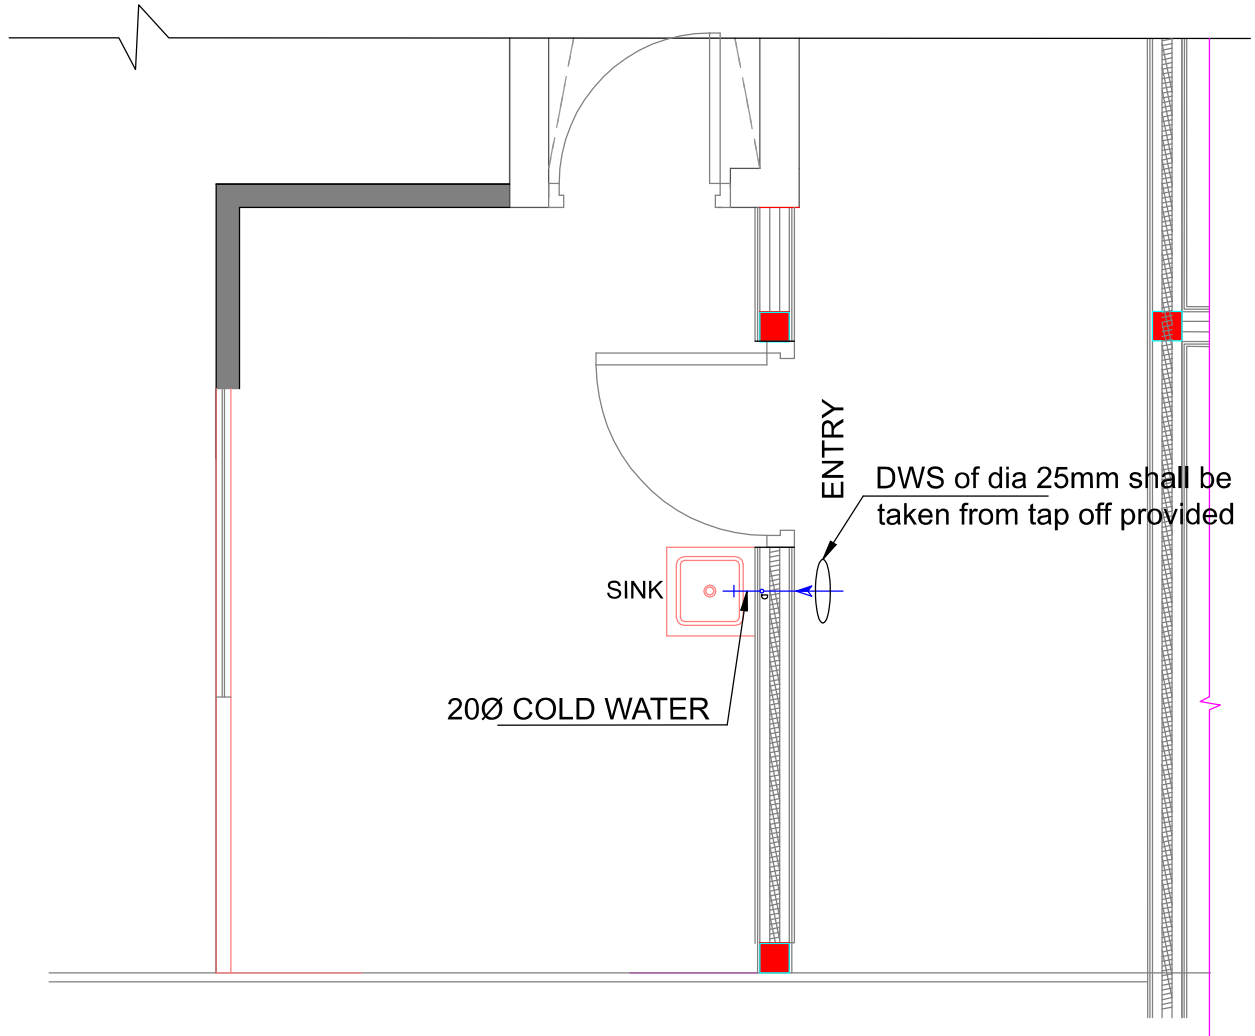

Note:
Water Meter (AQUAMET MAKE) shall be installed

PHE LEGEND	
	WASTE PIPE (WP)
	DOMESTIC WATER SUPPLY (DWS)
	HOT WATER SUPPLY (HWS)
	FLOOR TRAP (FT)
	DROP

NOTE

1. All dimensions are in mm, unless specified.
2. Do not scale this drawing, only written dimensions need to be followed.
3. Any discrepancy in the drawing, to be brought to the notice of Architect.

 
The copy rights of this document is with SAMRAT ASSOCIATES, and it shouldn't be used by anybody without the written permission of Architect.

CLIENT:

M/S CREAM STONE

PROJECT/LOCATION:

CREAM STONE, DSHA @HYD AIRPORT



TITLE:

WATER SUPPLY LAYOUT

DRAWN: RACHANA

DATE: 07-03-2024

SCALE : NOT TO SCALE

ARCHITECTS

SAMRAT ASSOCIATES


Architecture | Interiors | Project Management

Khajaguda, Prashant Hills

Hyderabad,

040-23311009


E mail: samratarchitects@gmail.com

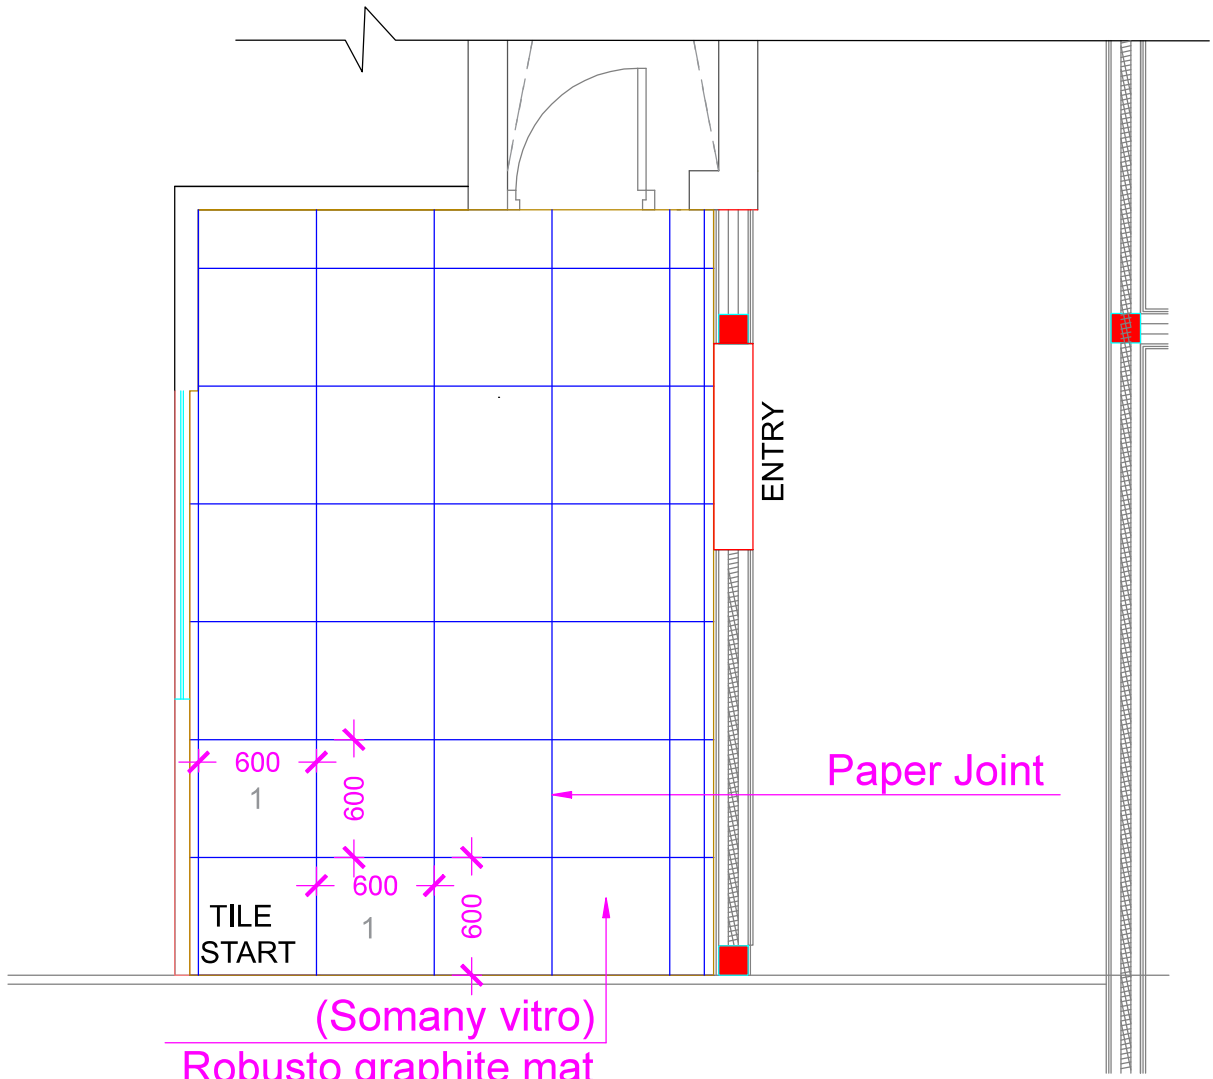

TILE SIZE - 600 x 600mm
FLOOR AREA- 10.36 SQ.MT
112 SFT

NOTE 1. All dimensions are in mm, unless specified. 2. Do not scale this drawing, only written dimensions need to be followed. 3. Any discrepancy in the drawing, to be brought to the notice of Architect.	CLIENT: M/S CREAM STONE		TITLE: FLOORING PLAN	ARCHITECTS SAMRAT ASSOCIATES Architecture Interiors Project Management Khajaguda, Prashant Hills Hyderabad, 040-23311009 E mail: samratarchitects@gmail.com
	PROJECT/LOCATION: CREAM STONE, DSHA @HYD AIRPORT		DRAWN: BUSHRA DATE: 08-04-2024 SCALE : NOT TO SCALE	

The copy rights of this document is with SAMRAT ASSOCIATES, and it shouldn't be used by anybody without the written permission of Architect.

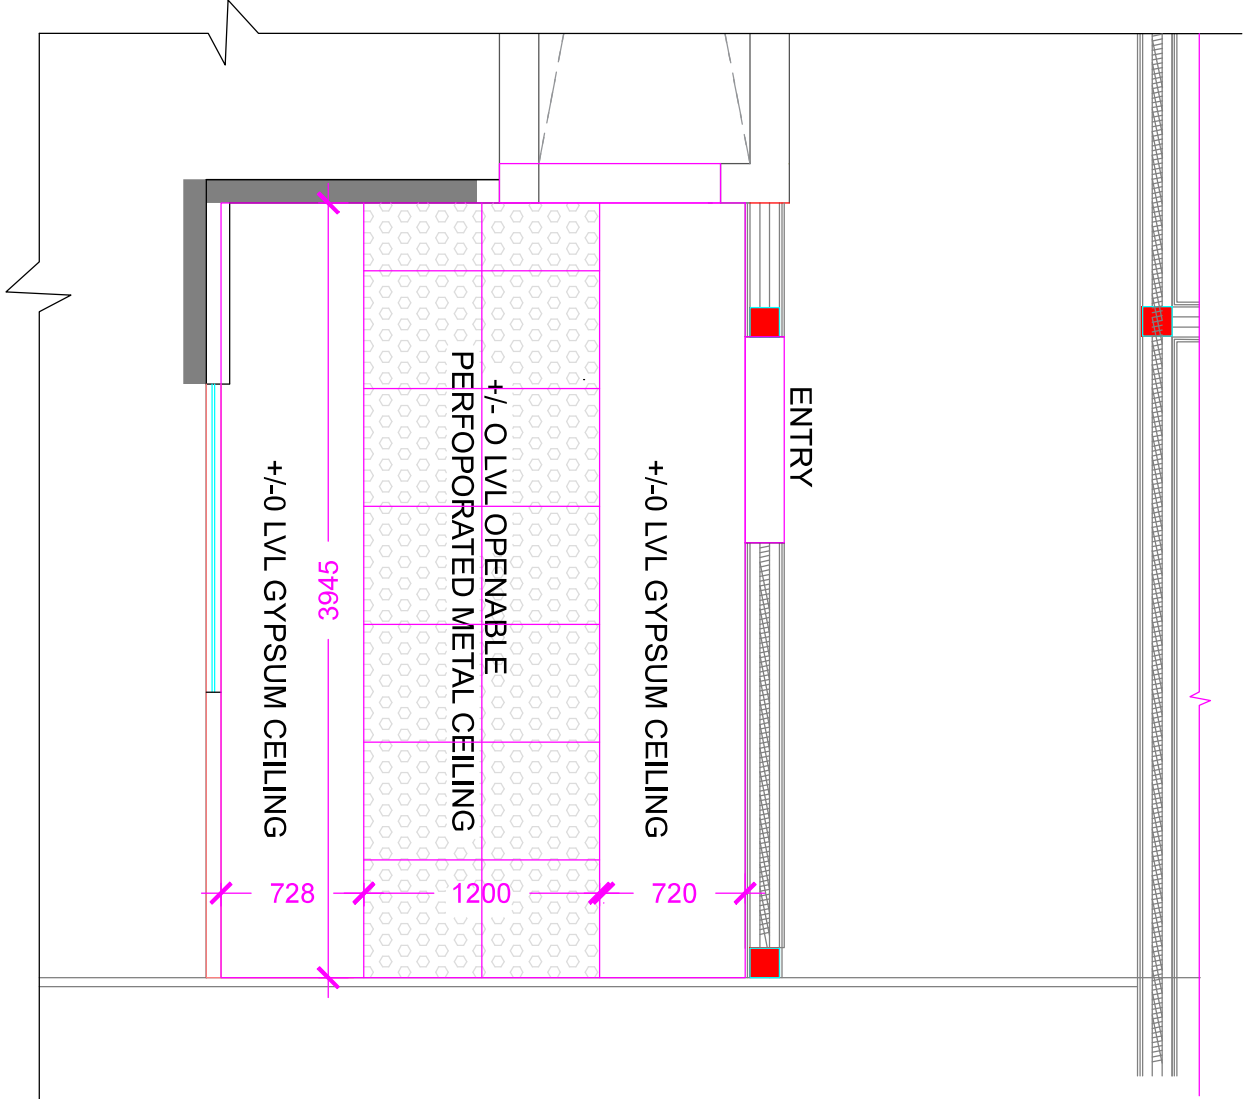


CEILING HEIGHT -3000mm

NOTE
 1. All dimensions are in mm, unless specified.
 2. Do not scale this drawing, only written dimensions need to be followed.
 3. Any discrepancy in the drawing, to be brought to the notice of Architect.

The copy rights of this document is with SAMRAT ASSOCIATES, and it shouldn't be used by anybody without the written permission of Architect.

CLIENT:
 M/S CREAM STONE

PROJECT/LOCATION:
 CREAM STONE, DSHA
 @HYD AIRPORT

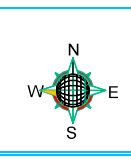

TITLE:
 FALSE CEILING PLAN


DRAWN: BUSHRA

DATE: 08-04-2024

SCALE: NOT TO SCALE

ARCHITECTS
SAMRAT ASSOCIATES
 Architecture | Interiors | Project Management


Khajaguda, Prashant Hills
 Hyderabad,
 040-23311009
 E mail: samratarchitects@gmail.com

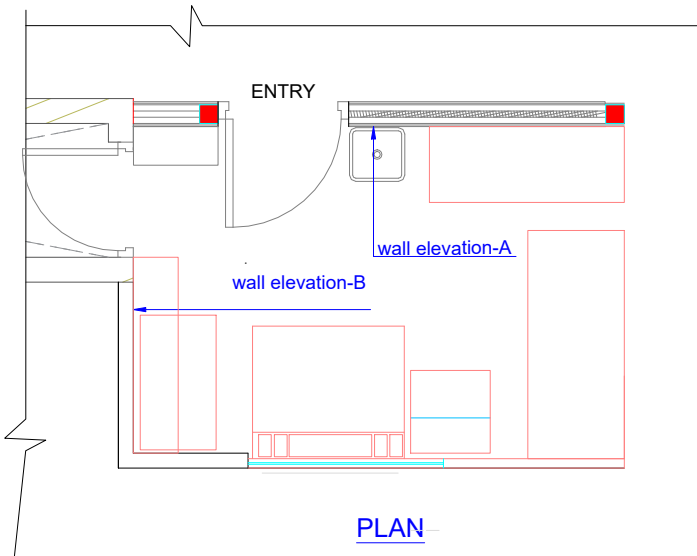


PLAN




3D VIEW

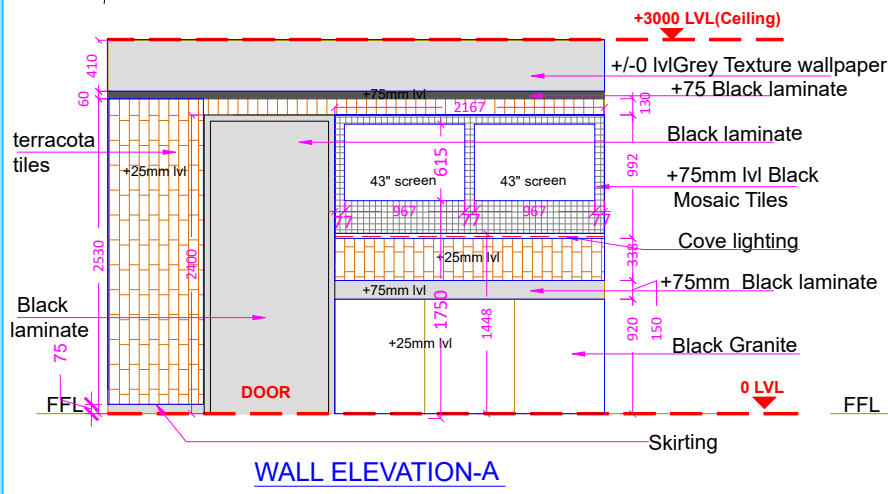

WALL ELEVATION-A

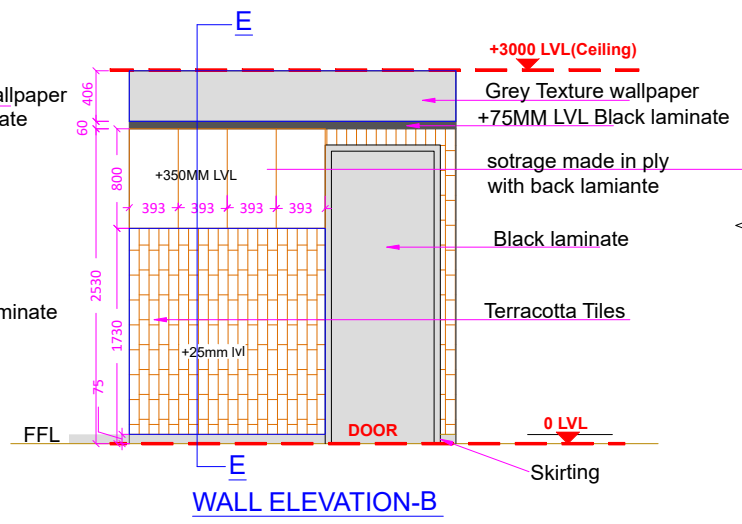

WALL ELEVATION-B

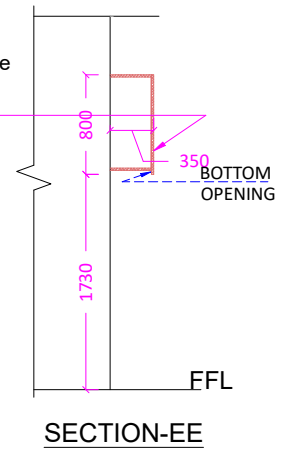


SECTION-EE

NOTE
 1. All dimensions are in mm, unless specified.
 2. Do not scale this drawing, only written dimensions need to be followed.
 3. Any discrepancy in the drawing, to be brought to the notice of Architect.

The copy rights of this document is with SAMRAT ASSOCIATES, and it shouldn't be used by anybody without the written permission of Architect.

CLIENT:
M/S CREAM STONE

PROJECT/LOCATION:
CREAM STONE, WEST BULB @HYD AIRPORT

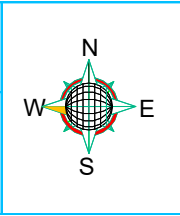

TITLE:
WALL ELEVATIONS


DRAWN: BUSHRA

DATE: 08-04-2024


SCALE : NOT TO SCALE

ARCHITECTS
SAMRAT ASSOCIATES
 Architecture | interiors | Project Management


Khajaguda, Prashant Hills
 Hyderabad.
 040-23311009
 e mail: samratarchitects@gmail.com

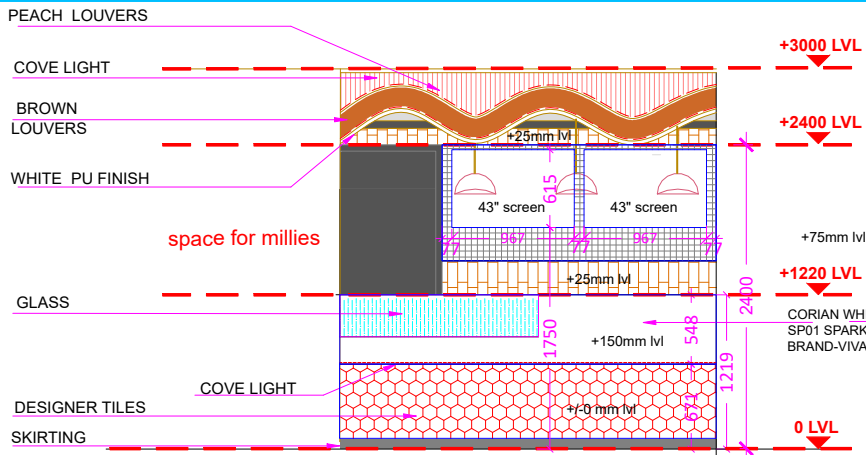


FRONT EXTERIOR ELEVATION

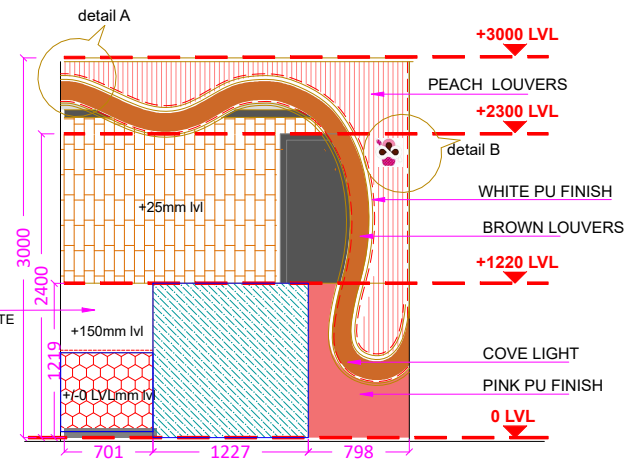

SIDE EXTERIOR ELEVATION

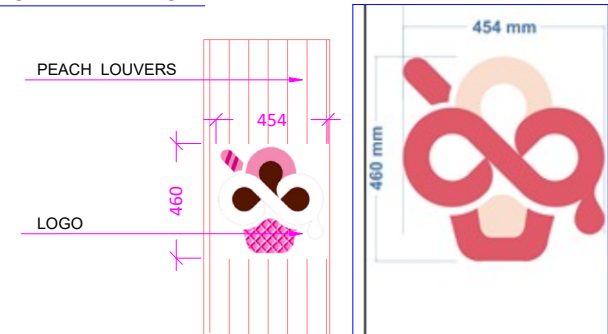

DETAIL-B

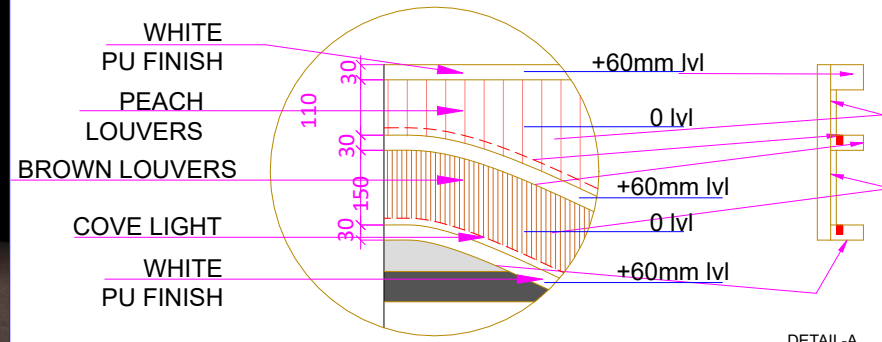

DETAIL-A

**DETAIL-A
SIDE SECTION**

NOTE

1. All dimensions are in mm, unless specified.
2. Do not scale this drawing, only written dimensions need to be followed.
3. Any discrepancy in the drawing, to be brought to the notice of Architect.


The copy rights of this document is with SAMRAT ASSOCIATES, and it shouldn't be used by anybody without the written permission of Architect.

CLIENT:

M/S CREAM STONE

PROJECT/LOCATION:

CREAM STONE, WEST BULB @HYD AIRPORT

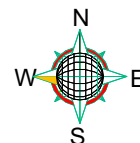

TITLE:

EXTERIOR ELEVATIONS

DRAWN: BUSHRA

DATE: 08-04-2024

SCALE : NOT TO SCALE

ARCHITECTS


SAMRAT ASSOCIATES

Architecture | interiors | Project Management


Khajaguda, Prashant Hills
Hyderabad.

040-23311009


e mail: samratarchitects@gmail.com

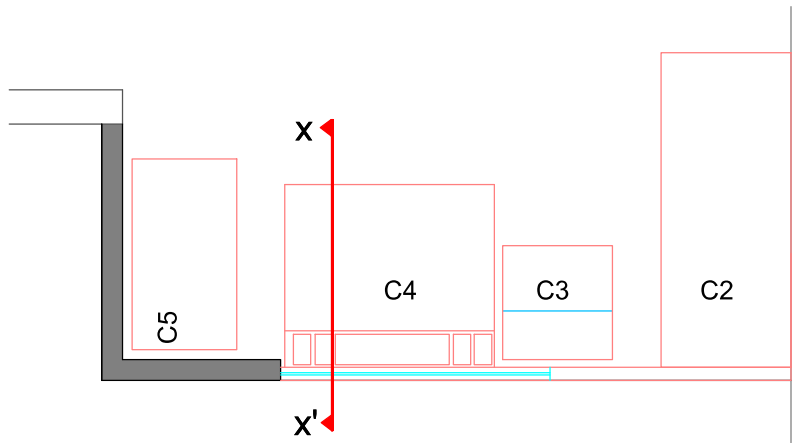


PLAN

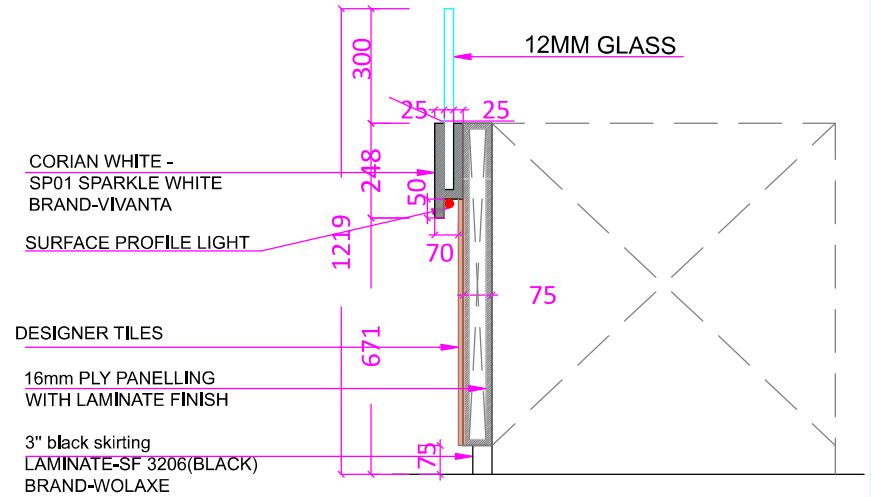

SECTION-XX'

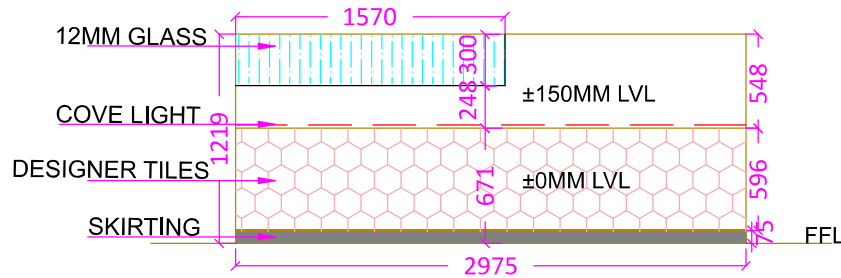

COUNTER FRONT ELEVATION

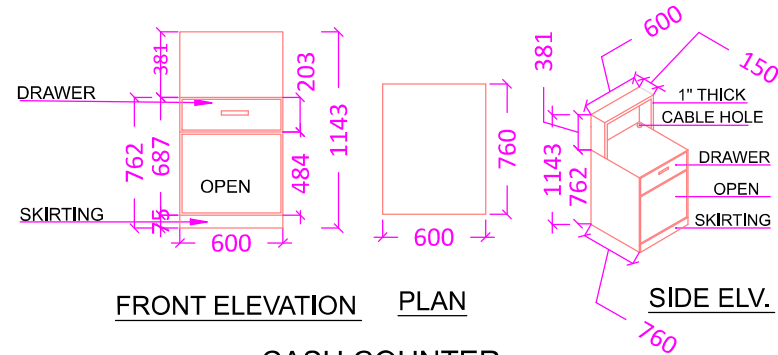

FRONT ELEVATION PLAN

CASH COUNTER

NOTE

1. All dimensions are in mm, unless specified.
2. Do not scale this drawing, only written dimensions need to be followed.
3. Any discrepancy in the drawing, to be brought to the notice of Architect.


The copy rights of this document is with SAMRAT ASSOCIATES, and it shouldn't be used by anybody without the written permission of Architect.

CLIENT:

M/S CREAM STONE

PROJECT/LOCATION:

**CREAM STONE, WEST BULB
@HYD AIRPORT**

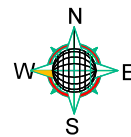

TITLE:

COUNTER DETAILS

DRAWN: BUSHRA

DATE: 08-04-2024

SCALE : NOT TO SCALE

ARCHITECTS

SAMRAT ASSOCIATES

Architecture | interiors | Project Management
Khajaguda, Prashant Hills

Hyderabad.

040-23311009

e mail: samratarchitects@gmail.com



NOTE

- 1. All dimensions are in mm, unless specified.
- 2. Do not scale this drawing, only written dimensions need to be followed.
- 3. Any discrepancy in the drawing, to be brought to the notice of Architect.


The copy rights of this document is with SAMRAT ASSOCIATES, and it shouldn't be used by anybody without the written permission of Architect.

CLIENT:

M/S CREAM STONE

PROJECT/LOCATION:

CREAM STONE, DSHA @HYD AIRPORT

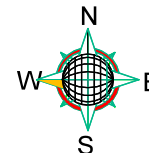

TITLE:

3D VIEWS

DRAWN: BUSHRA

DATE: 08-04-2024

SCALE : NOT TO SCALE

ARCHITECTS

SAMRAT ASSOCIATES


Architecture | interiors | Project Management

Khajaguda, Prashant Hills

Hyderabad.

040-23311009

E mail: samratarchitects@gmail.com

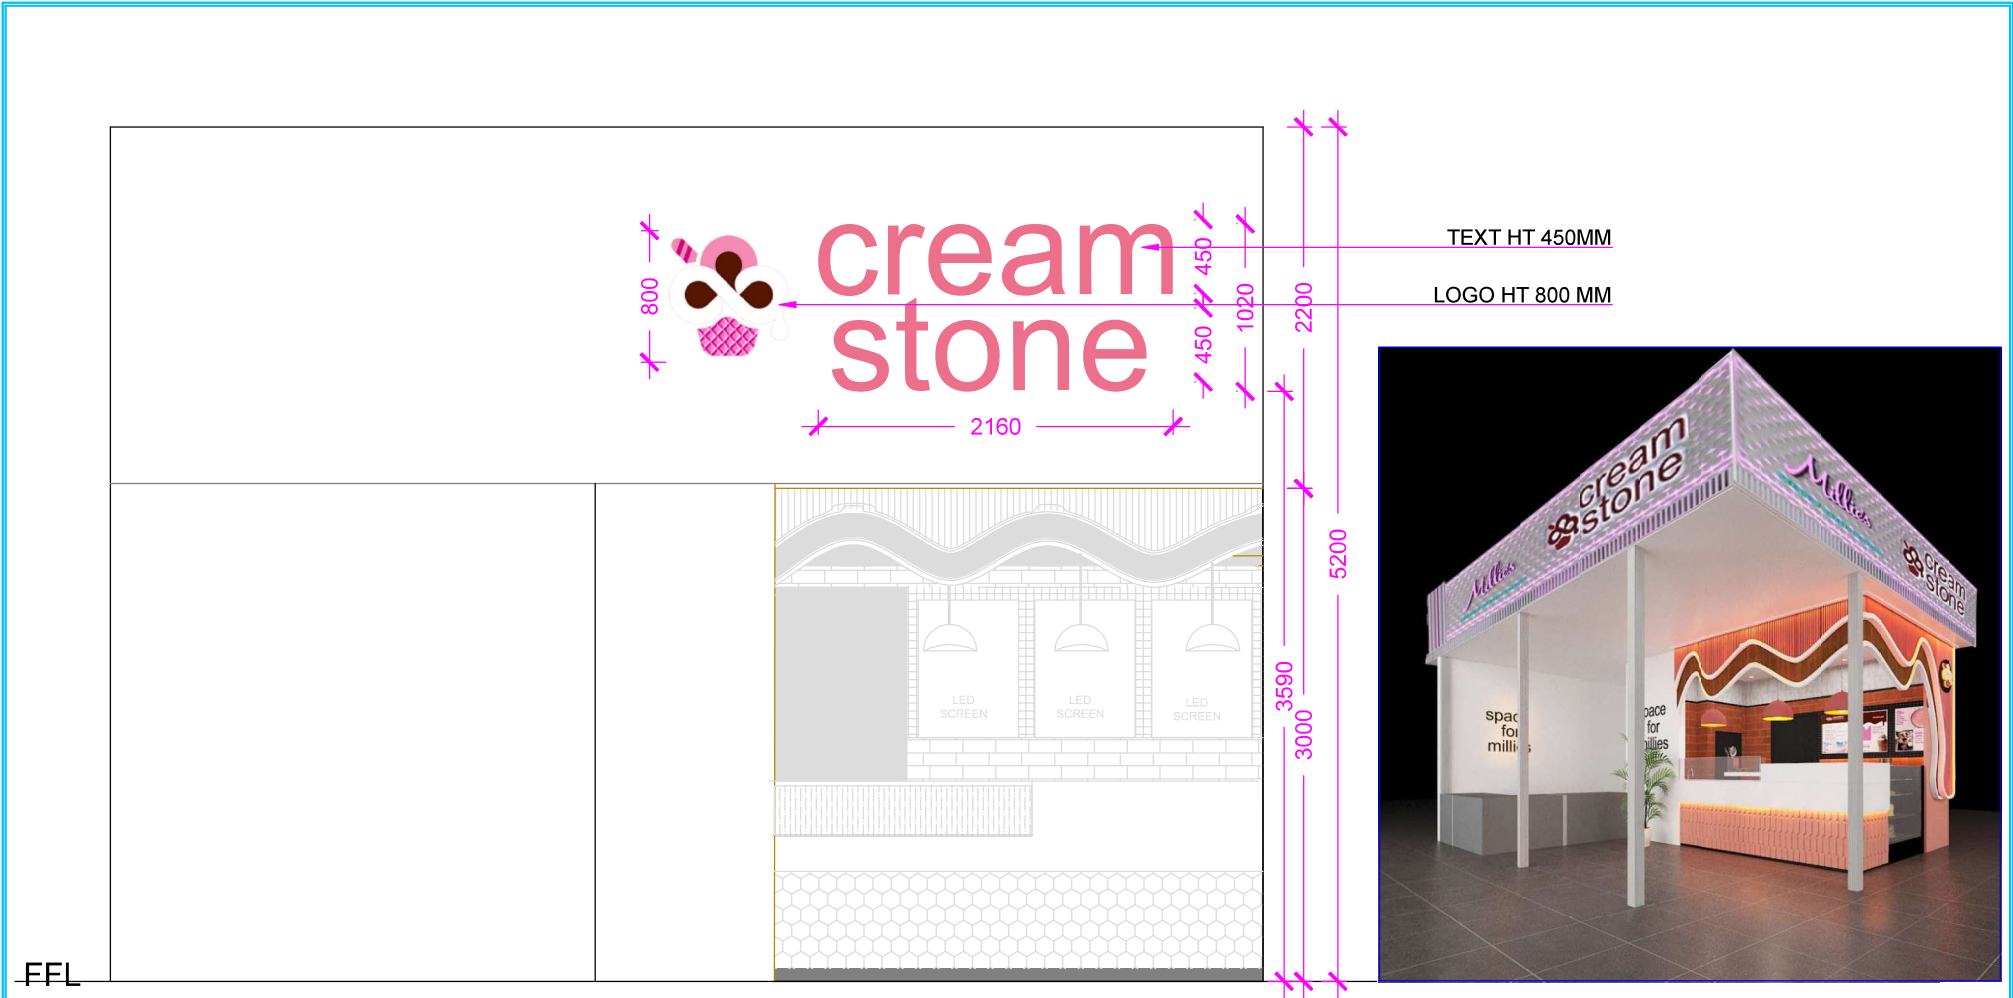

FFL

NOTE
 1. All dimensions are in mm, unless specified.
 2. Do not scale this drawing, only written dimensions need to be followed.
 3. Any discrepancy in the drawing, to be brought to the notice of Architect.

The copy rights of this document is with SAMRAT ASSOCIATES, and it shouldn't be used by anybody without the written permission of Architect.

CLIENT:
 M/S CREAM STONE

PROJECT/LOCATION:
 CREAM STONE, WEST BULB @HYD AIRPORT


TITLE:
 SIGNAGE DETAILS

DRAWN: BUSHRA

DATE: 08-04-2024

SCALE : NOT TO SCALE

ARCHITECTS
SAMRAT ASSOCIATES
 Architecture | interiors | Project Management
 Khajaguda, Prashant Hills
 Hyderabad.
 040-23311009
 e mail: samratarchitects@gmail.com

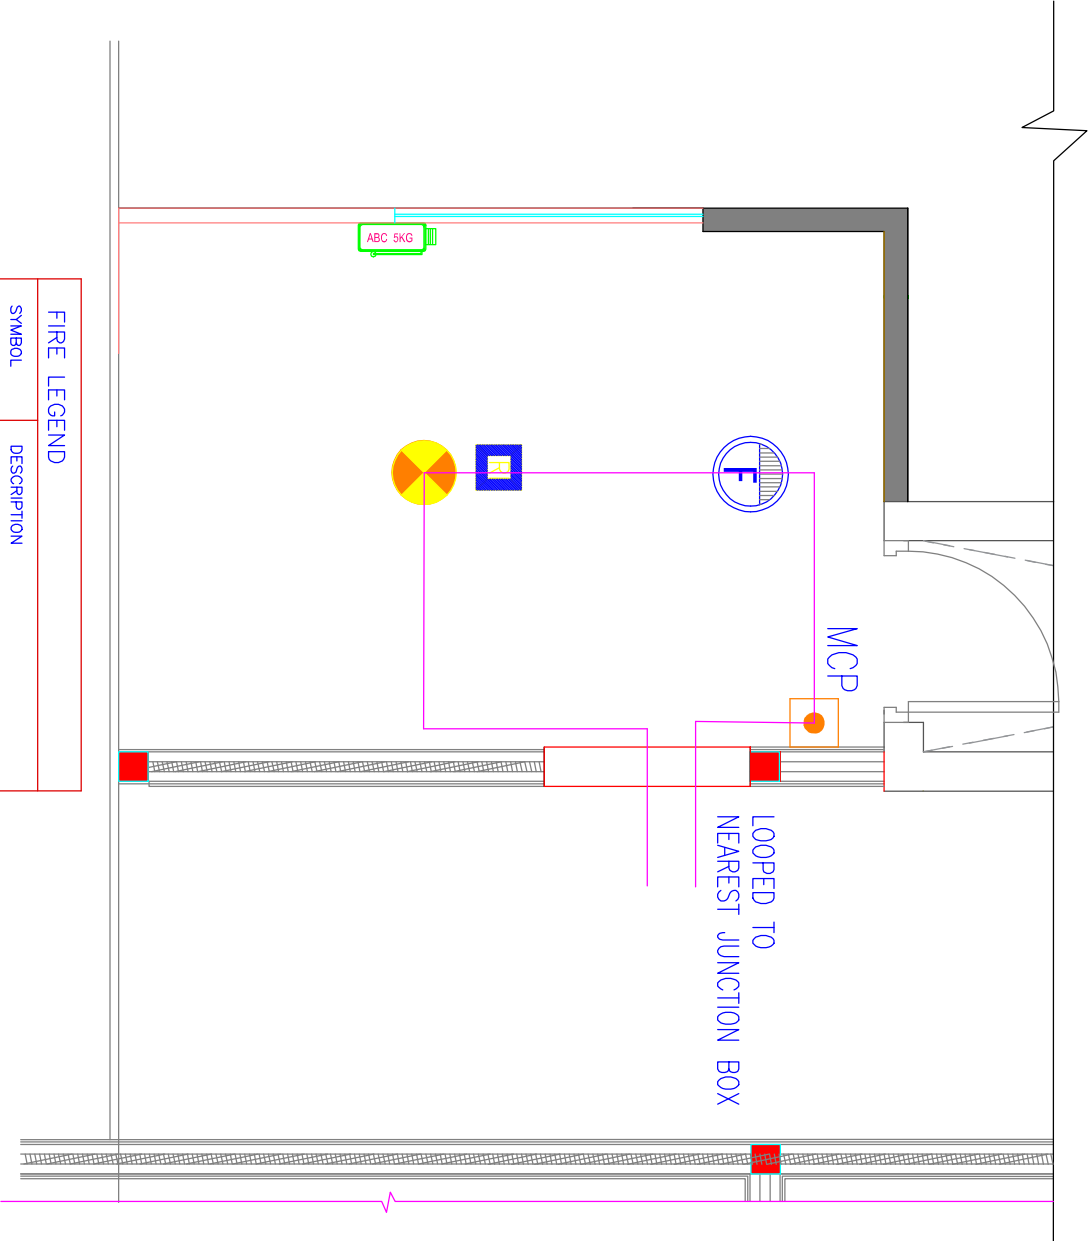

FIRE LEGEND	
SYMBOL	DESCRIPTION
	SPRINKLER BRANCH PIPE
	PENDENT SPRINKLER
	BELOW SMOKE DETECTOR
	5.0KG-ABC EXTINGUISHER
	UPRIGHT SPRINKLER
	ABOVE SMOKE DETECTOR
	RESPONSE INDICATOR
	FAULT ISOLATOR

 
NOTE

- All dimensions are in mm, unless specified.
- Do not scale this drawing, only written dimensions need to be followed.
- Any discrepancy in the drawing, to be brought to the notice of Architect.

The copy rights of this document is with SAMRAT ASSOCIATES, and it should not be used by anybody without the written permission of Architect.

CLIENT:
M/S CREAM STONE

PROJECT/LOCATION:
CREAM STONE, DSHA @HYD AIRPORT




TITLE:
FIRE ALARM LAYOUT

DRAWN: RACHANA
DATE: 08-04-2024

SCALE: NOT TO SCALE

ARCHITECTS:
SAMRAT ASSOCIATES
Architecture | Interior | Project Management

Khaiguda, Prashant Hills
Hyderabad.
040-23311009
E mail: samratarchitects@gmail.com

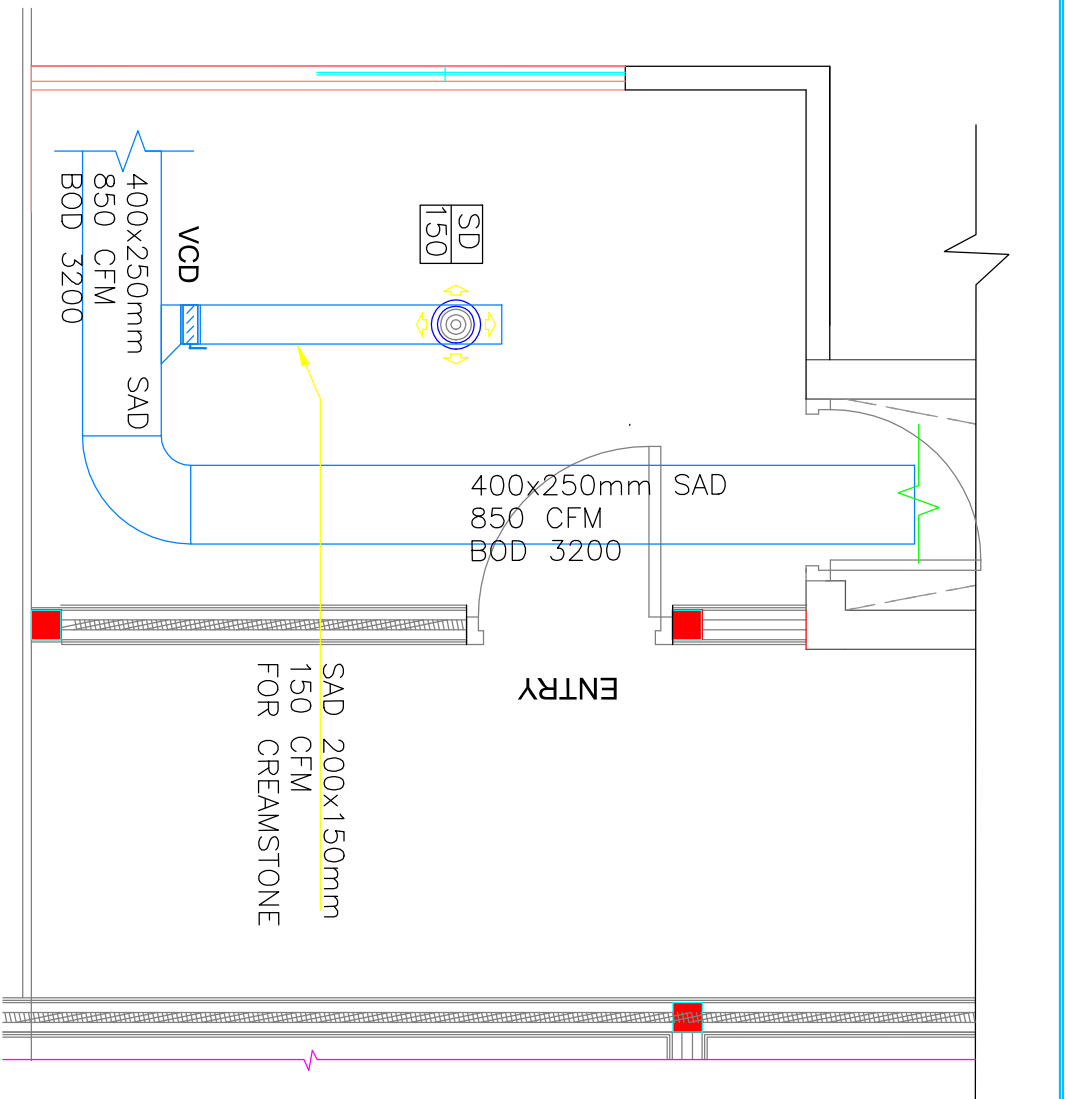


NOTE

1. All dimensions are in mm, unless specified.
2. Do not scale this drawing, only written dimensions need to be followed.
3. Any discrepancy in the drawing, to be brought to the notice of Architect.

The copyrights of this document is with SAMRAT ASSOCIATES, and it shall be used by permission of Architect.

CLIENT
M/S CREAM STONE

 
PROJECT/LOCATION:
CREAM STONE, DSHA @HYD AIRPORT



TITLE:
HVAC LAYOUT

DRAWN: BUSHRA
DATE: 08-04-2024
SCALE: NOT TO SCALE

ARCHITECTS
SAMRAT ASSOCIATES
Architecture | Interior | Project Management
Khaiguda Pashant Hills
Hyderabad
046-23311009
E mail: samrataarchitects@gmail.com

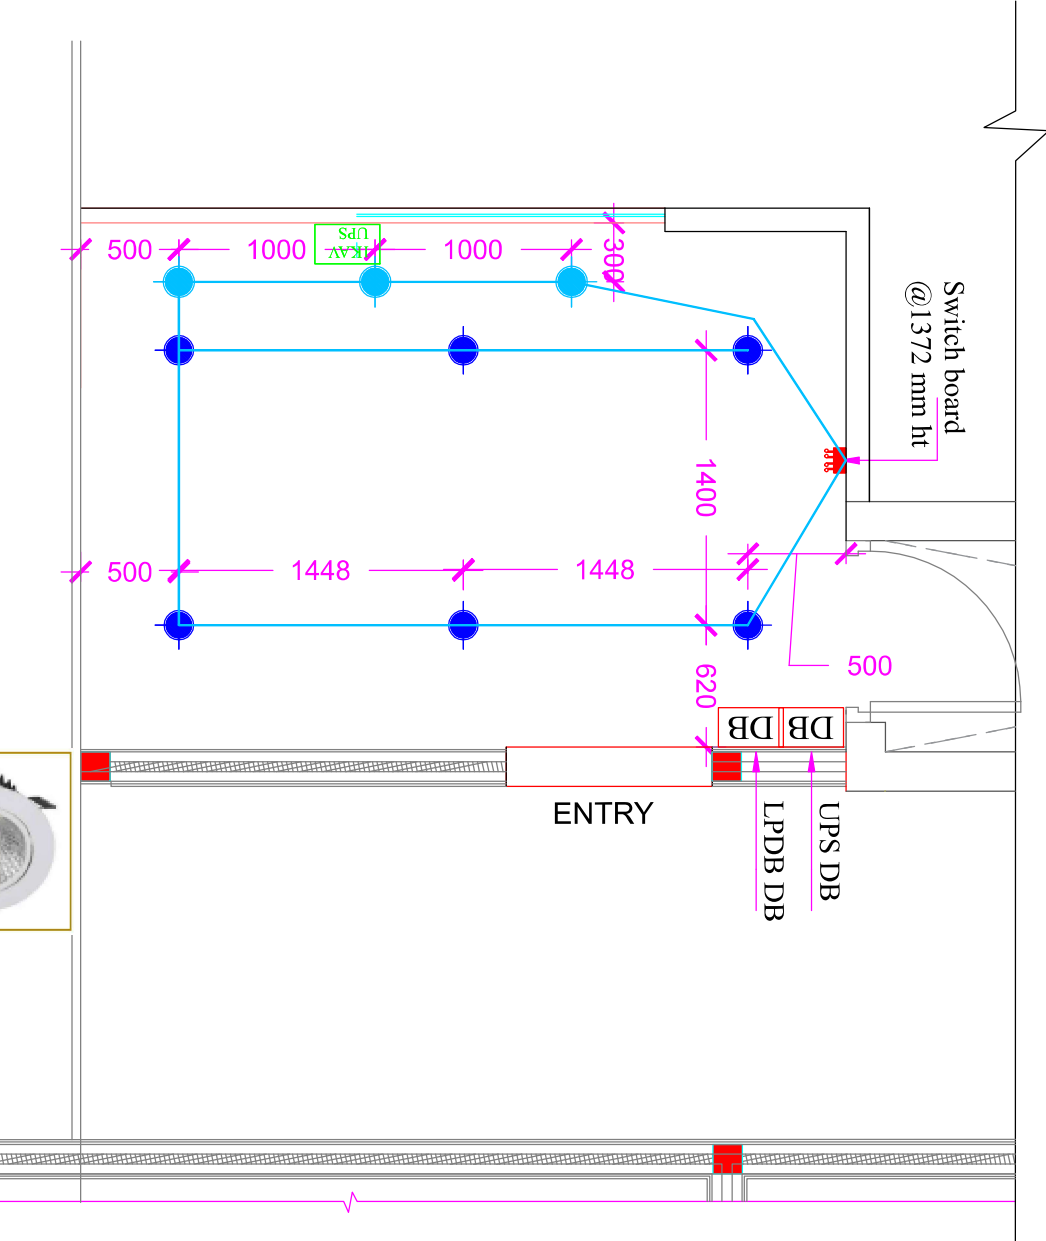

ELECTRICAL LEGEND-CONDUIT

SYMBOL	DESCRIPTION
	25mmø PVC CONDUIT FOR POWER
	25mmø PVC CONDUIT FOR LIGHTING
	25mmø PVC CONDUIT FOR TEL&DATA
	25mmø PVC CONDUIT FOR POINT WIRING
	25mmø PVC CONDUIT FOR CCTV
	25mmø PVC CONDUIT FOR EMERGENCY

ALL LIGHTS ARE WARM WHITE

- DOWNLIGHT COB 3000K(V(6NO))
- HANGING LIGHT(3NO) CCTV
- DOME SHAPED LAMP SHADE LED PENDENT LIGHT (DIA 300MM)


NOTE

- All dimensions are in mm, unless specified.
- Do not scale this drawing, only written dimensions need to be followed.
- Any discrepancy in the drawing, to be brought to the notice of Architect.

The copy rights of this document is with SAMRAT ASSOCIATES, and it shouldnt be used by anybody without the written permission of Architect.

CLIENT
M/S CREAM STONE


PROJECT/LOCATION:
CREAM STONE, DSHA @HYD AIRPORT

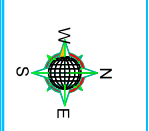





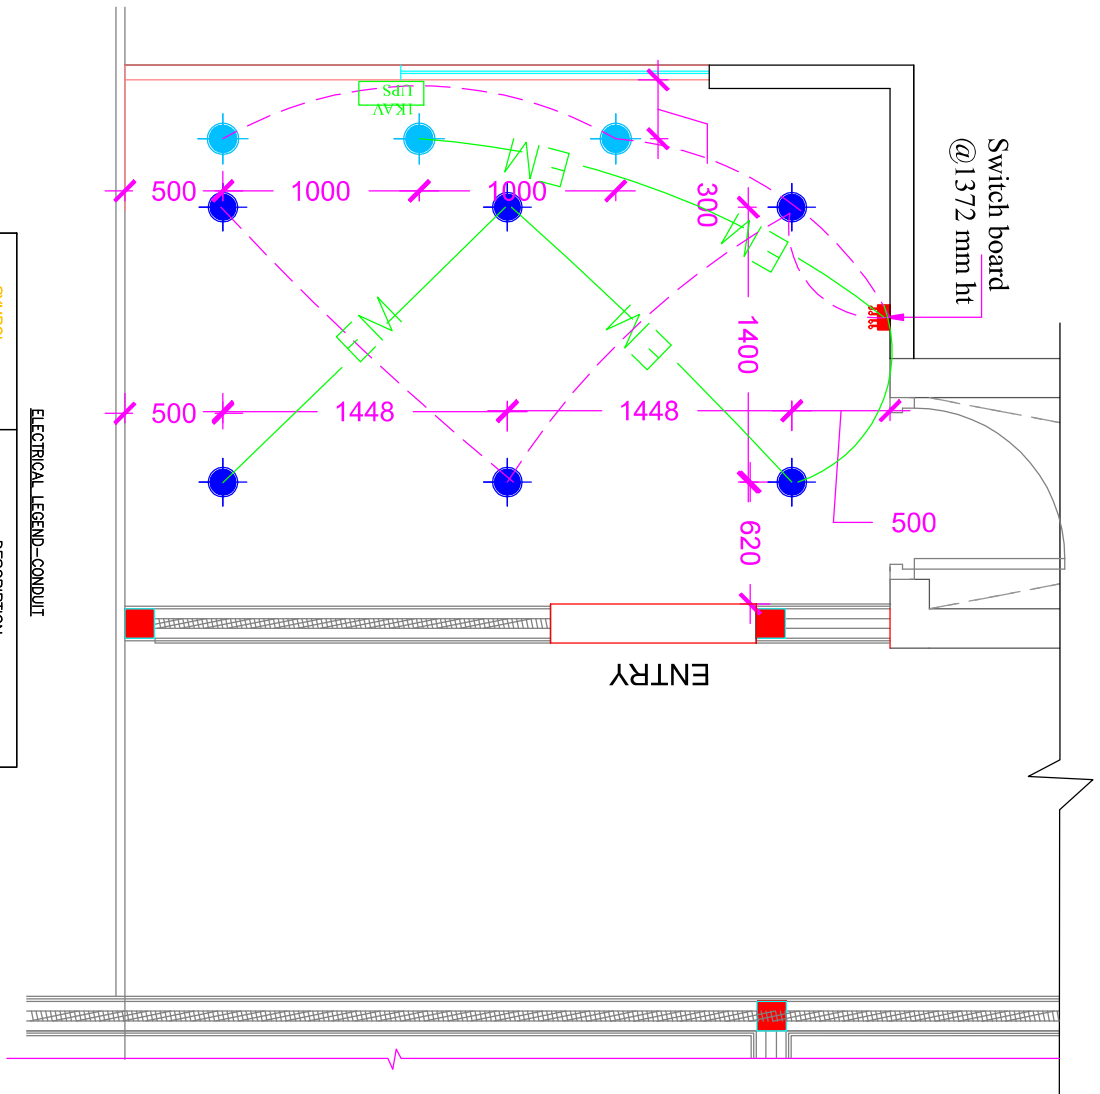

TITLE:
LIGHTING CONDUIT LAYOUT

DRAWN: RACHANA
DATE: 08-04-2024
SCALE: NOT TO SCALE

ARCHITECTS
SAMRAT ASSOCIATES
Architecture | Interior | Project Management
Khaiguda, Prashant Hills
Hyderabad.
040-23311009
E mail: samratarchitects@gmail.com



ELECTRICAL LEGEND-CONDUIT


SYMBOL	DESCRIPTION
	P 25mmø PVC CONDUIT FOR POWER
	L 25mmø PVC CONDUIT FOR LIGHTING
	ELV 25mmø PVC CONDUIT FOR TEL&DATA
	25mmø PVC CONDUIT FOR POINT WIRING
	25mmø PVC CONDUIT FOR CCTV
	25mmø PVC CONDUIT FOR EMERGENCY

NOTE


1. All dimensions are in mm, unless specified.
2. Do not scale this drawing, only written dimensions need to be followed.
3. Any discrepancy in the drawing, to be brought to the notice of Architect.

The copy rights of this document is with SAMRAT ASSOCIATES, and it should not be used by anybody without the written permission of Architect.

CLIENT	TITLE	ARCHITECTS
M/S CREAM STONE	LIGHTING LOOPING LAYOUT	SAMRAT ASSOCIATES
PROJECT/LOCATION: CREAM STONE, DSHA @HYD AIRPORT	DRAWN: RACHANA DATE: 08-04-2024 SCALE: NOT TO SCALE	Architecture Interior Project Management Khaiguda, Prashant Hills Hyderabad, 040-23311009 E mail: samratarchitects@gmail.com

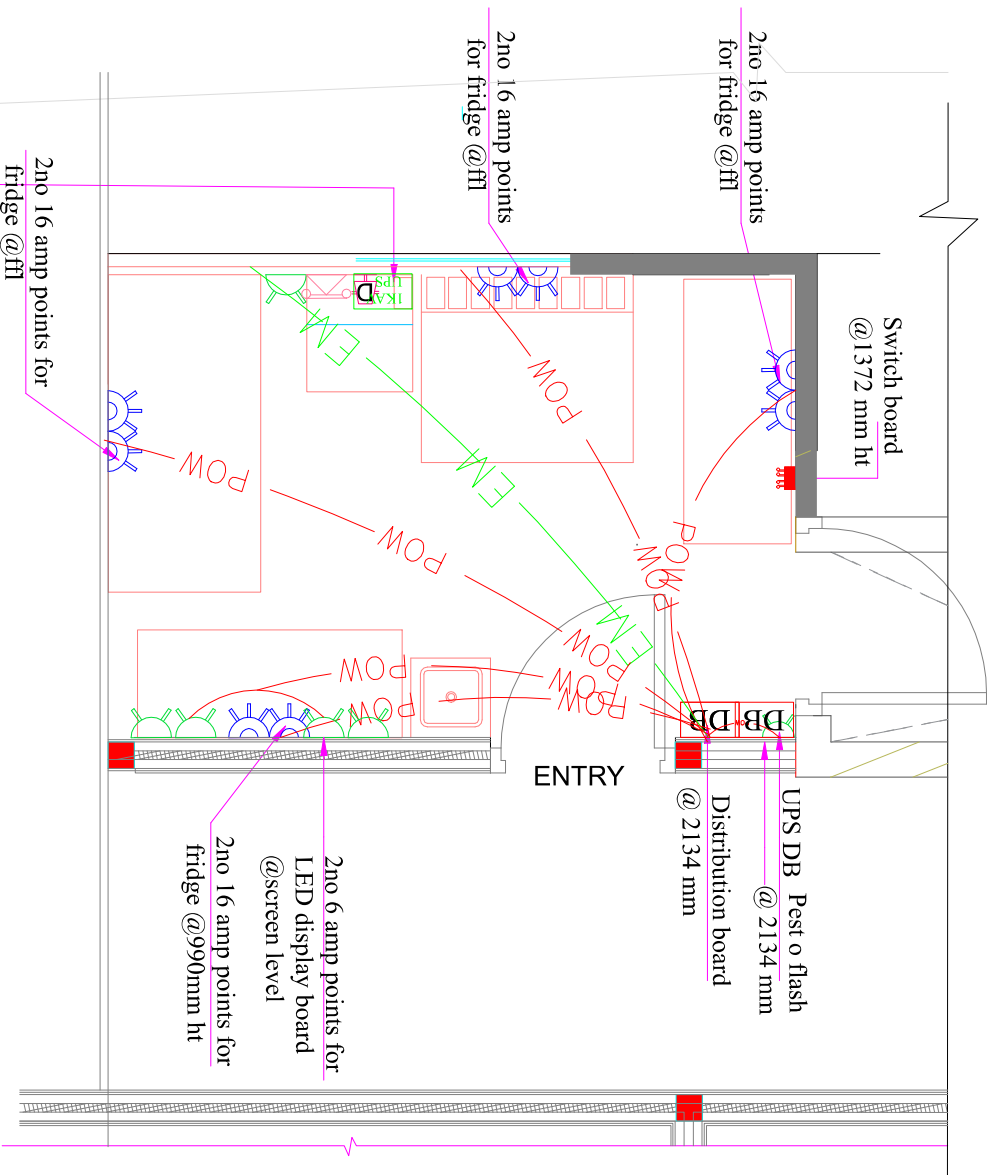

Computer connections for systems, telephone, internet, data, 2 nos 16 amps point @ floor lvl

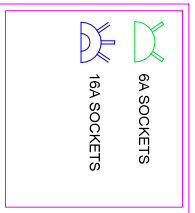


ELECTRICAL LEGEND-CONDUIT

SYMBOL	DESCRIPTION
P	25mm \varnothing PVC CONDUIT FOR POWER
L	25mm \varnothing PVC CONDUIT FOR LIGHTING
ELV	25mm \varnothing PVC CONDUIT FOR TEL&DATA
	25mm \varnothing PVC CONDUIT FOR POINT WIRING
cctv	25mm \varnothing PVC CONDUIT FOR CCTV


NOTE
 1. All dimensions are in mm, unless specified.
 2. Do not scale this drawing, only written dimensions need to be followed.
 3. Any discrepancy in the drawing, to be brought to the notice of Architect.
 The copy rights of this document is with SAMVRAT ASSOCIATES, and it should not be used by anybody without the written permission of Architect.

 CLIENT
 M/S CREAM STONE
 PROJECT/LOCATION:
 CREAM STONE, DSHA @HYD AIRPORT





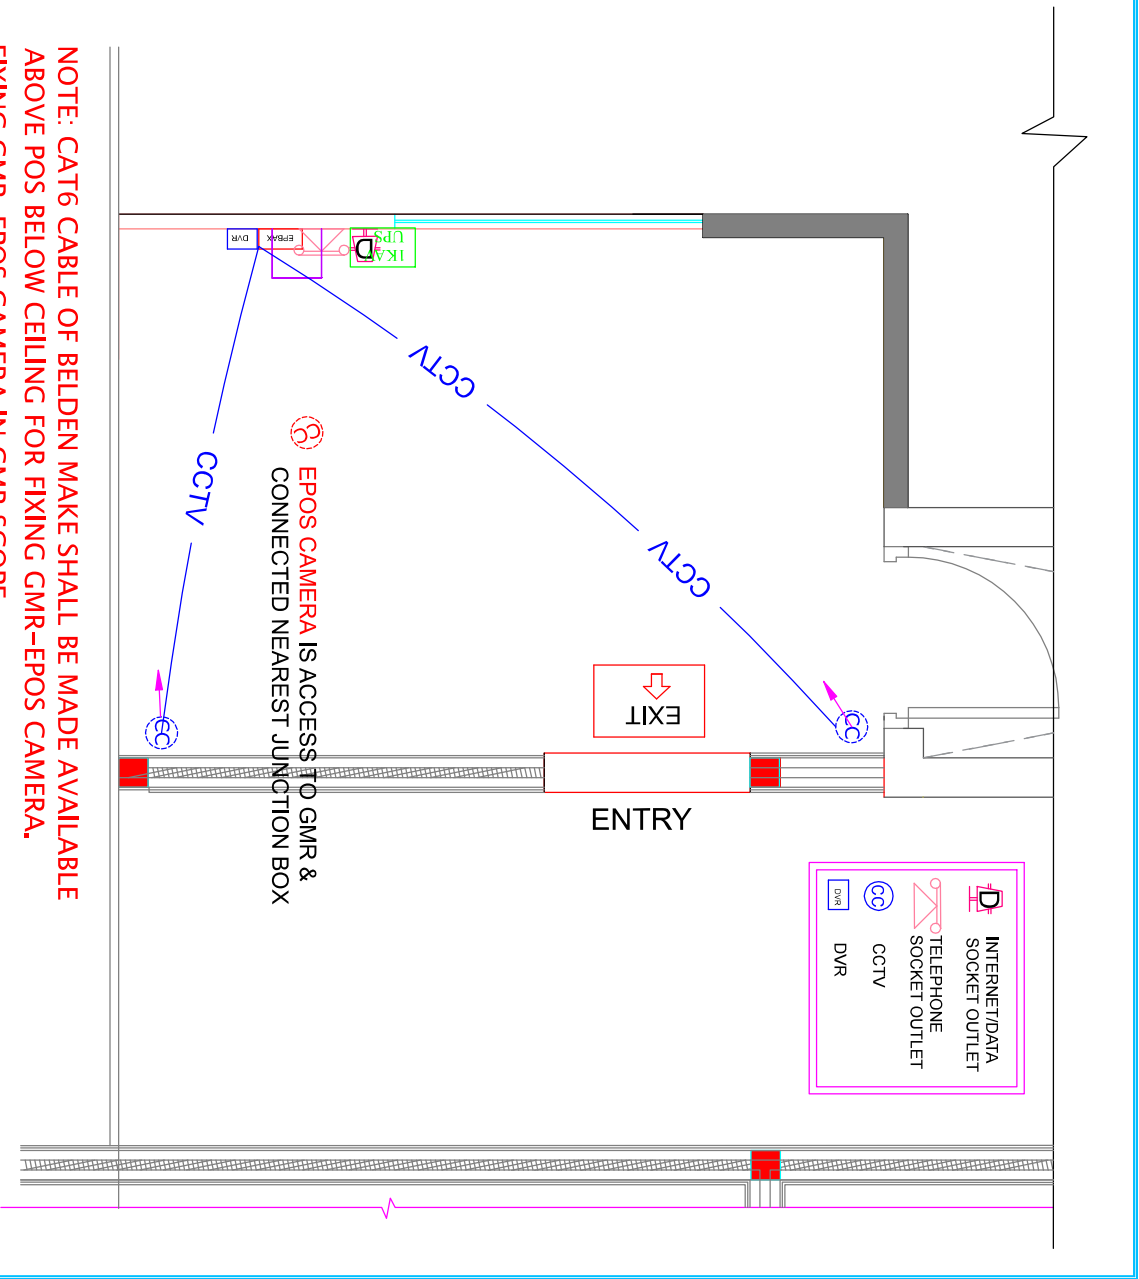


TITLE:
 POWER LOOPING
 DRAWN: BUSHRA
 DATE: 08-04-2024
 SCALE: NOT TO SCALE

ARCHITECTS
 SAMVRAT ASSOCIATES
 Architectural | Interior | Project Management
 Khataguda, Prashant Hills
 Hyderabad.
 040-23311009
 E mail: samvratarchitects@gmail.com



 
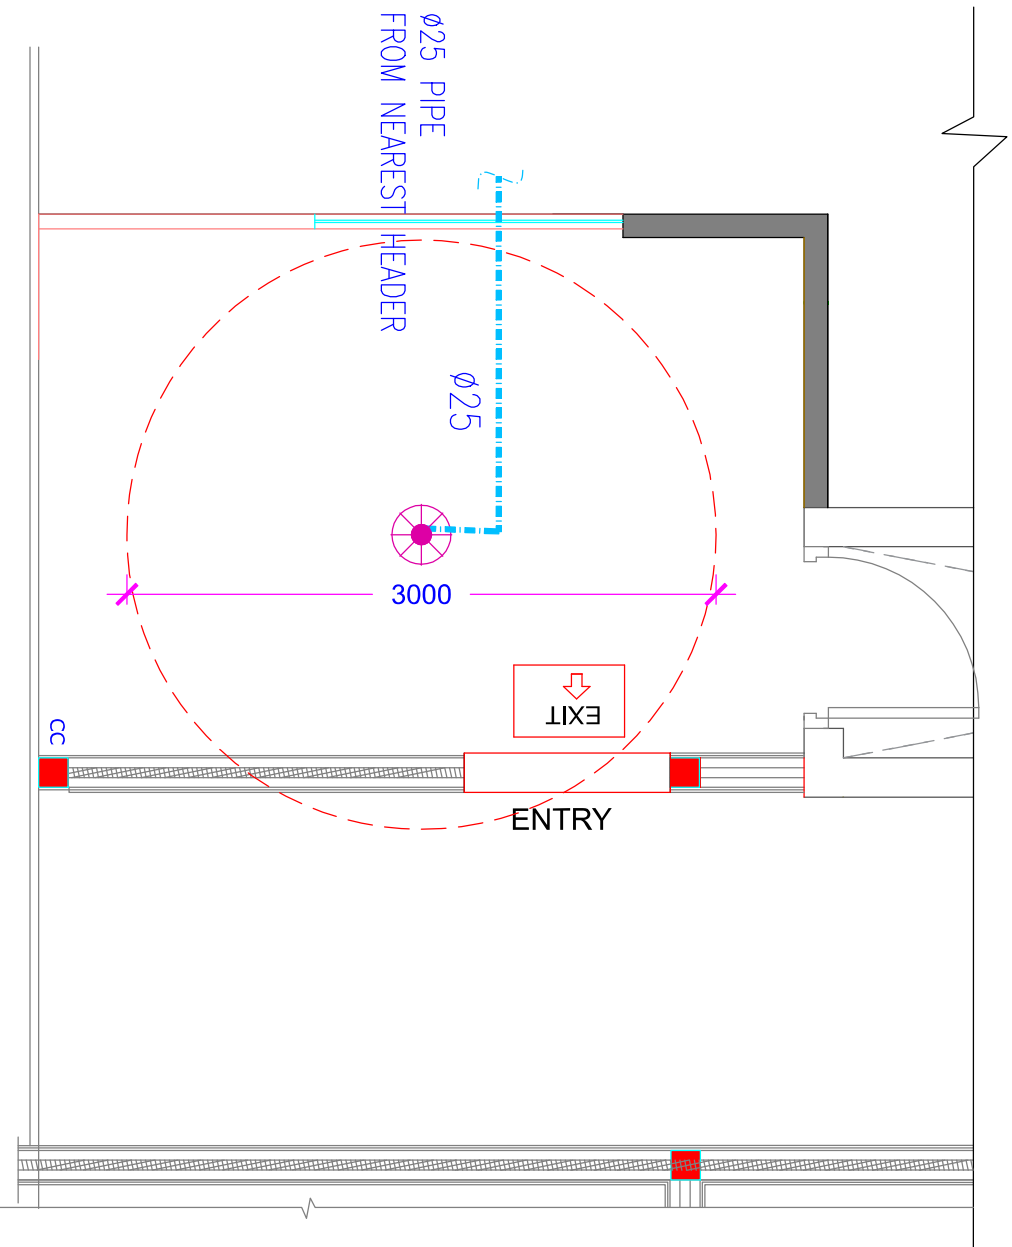
NOTE: CAT6 CABLE OF BELDEN MAKE SHALL BE MADE AVAILABLE ABOVE POS BELOW CEILING FOR FIXING GMR-EPOS CAMERA, FIXING GMR-EPOS CAMERA IN GMR SCOPE

ELECTRICAL LEGEND-CONDUIT

SYMBOL	DESCRIPTION
 P	25mm ϕ PVC CONDUIT FOR POWER
 L	25mm ϕ PVC CONDUIT FOR LIGHTING
 ELV	25mm ϕ PVC CONDUIT FOR TEL&DATA
	25mm ϕ PVC CONDUIT FOR POINT WIRING
 CCTV	25mm ϕ PVC CONDUIT FOR CCTV

NOTE
 1. All dimensions are in mm, unless specified.
 2. Do not scale this drawing, only written dimensions need to be followed.
 3. Any discrepancy in the drawing, to be brought to the notice of Architect.
 The copy rights of this document is with SAMRAT ASSOCIATES, and it should not be used by anybody without the written permission of Architect.

CLIENT M/S CREAM STONE	TITLE CCTV & IT LAYOUT
PROJECT/LOCATION: CREAM STONE, DSHA @HYD AIRPORT	ARCHITECTS SAMRAT ASSOCIATES Architecture Interior Project Management Khaiguda, Prashant Hills Hyderabad, 040-23311009 E mail: samratarchitects@gmail.com
	DATE: 08-04-2024 SCALE: NOT TO SCALE
	DRAWN: RACHANA SCALE: NOT TO SCALE



- NOTE:**
1. ISOLATION VALVE (AUDCO MAKE) OF PN16 RATING SHALL BE INSTALLED AT THE TAP OFF.
 2. DRAIN VALVE AND PRESSURE GAUGE SHALL BE PROVIDED AFTER BFV.
 3. TRAP DOOR TO ACCESS THE VALVES.
 4. SPRINKLER MARKING IS DONE AS PER MAX DIS 2700MM AND MIN DISTANCE 1500MM
 5. COVERAGE AREA OF SPRINKLER IS 3000MM

FIRE LEGEND	
SYMBOL	DESCRIPTION
	SPRINKLER BRANCH PIPE
	PENDENT SPRINKLER
	BELOW SMOKE DETECTOR
	5.0KG-ABC EXTINGUISHER
	UPRIGHT SPRINKLER
	ABOVE SMOKE DETECTOR
	RESPONSE INDICATOR
	FAULT ISOLATOR

 
NOTE

1. All dimensions are in mm, unless specified.
2. Do not scale this drawing, only written dimensions need to be followed.
3. Any discrepancy in the drawing to be brought to the notice of Architect.

The copy rights of this document is with SAMRAT ASSOCIATES, and it should not be used by anybody without the written permission of Architect.

CLIENT
M/S CREAM STONE


PROJECT/LOCATION:
CREAM STONE, DSHA @HYD AIRPORT



TITLE:
SPRINKLER LAYOUT

DRAWN: RAACHANA
DATE: 07-03-2024
SCALE: NOT TO SCALE

ARCHITECTS
SAMRAT ASSOCIATES
Architecture | Interior | Project Management
Khaiguda, Prashant Hills
Hyderabad.
040-23311009
E mail: samratarchitects@gmail.com

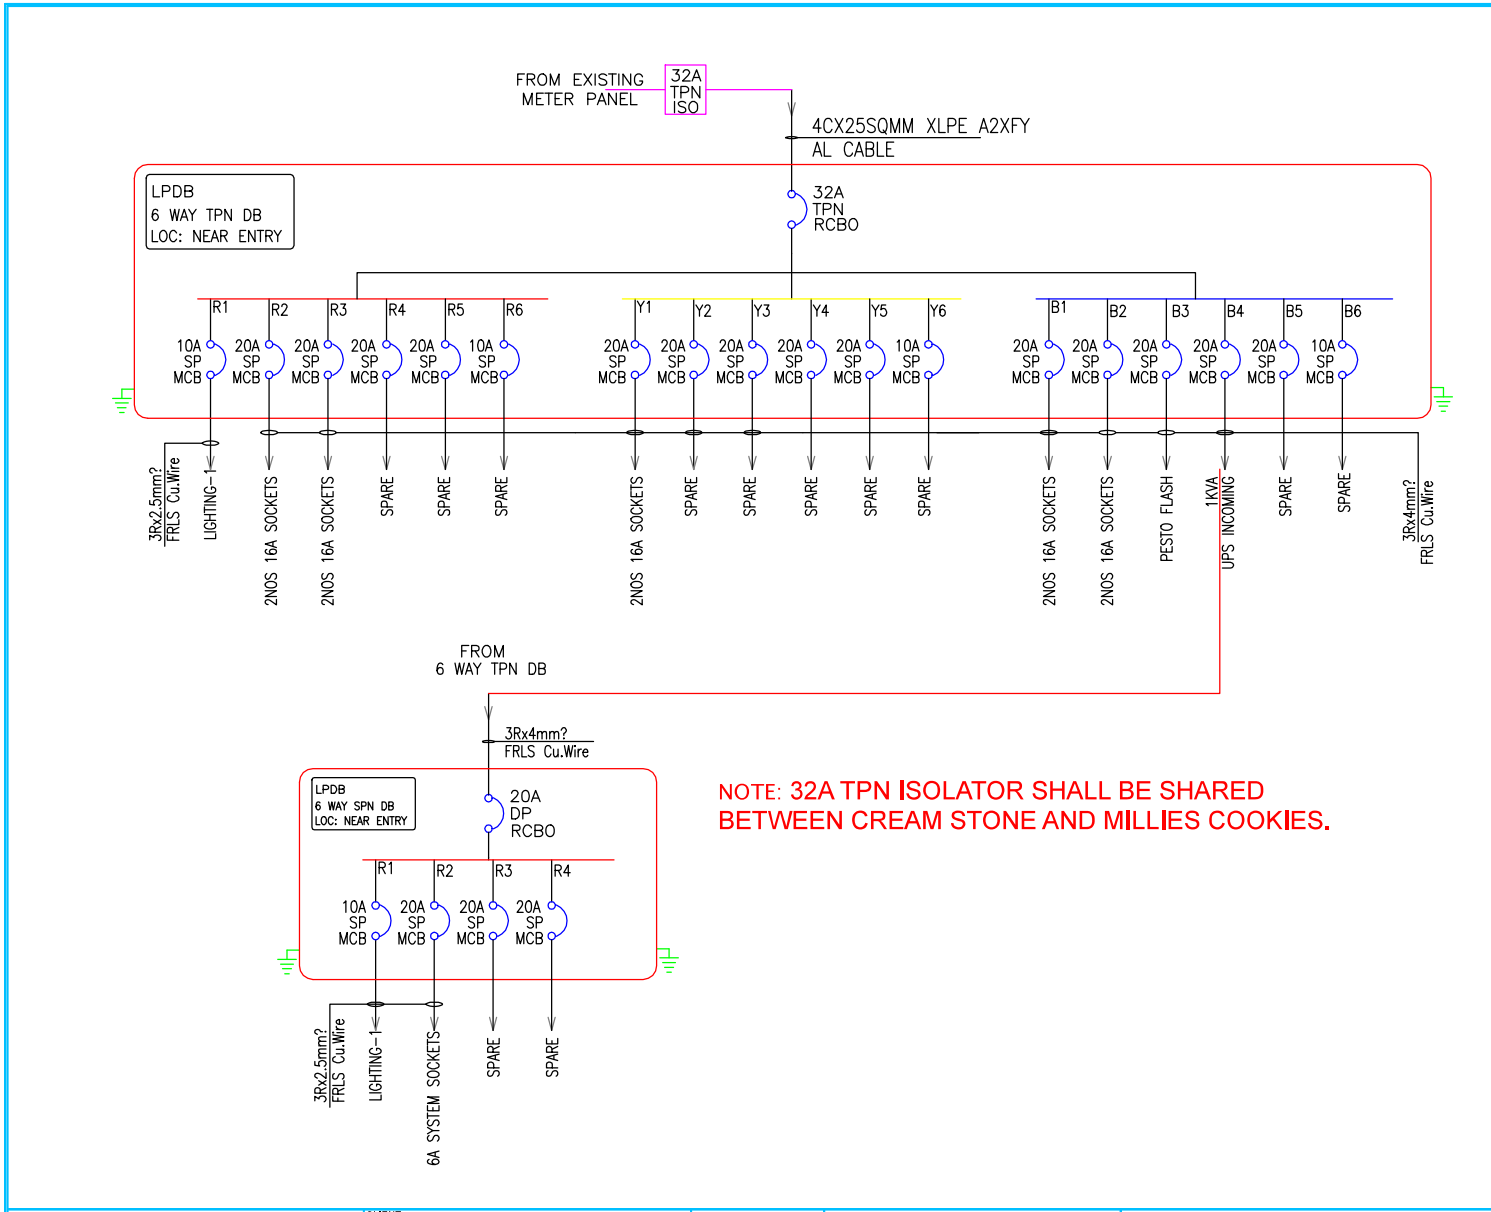


NOTE: 32A TPN ISOLATOR SHALL BE SHARED BETWEEN CREAM STONE AND MILLIES COOKIES.

NOTE

1. All dimensions are in mm, unless specified.
 2. Do not scale this drawing, only written dimensions need to be followed.
 3. Any discrepancy in the drawing, to be brought to the notice of Architect.
- The copy rights of this document is with SAMRAT ASSOCIATES, and it shouldn't be used by anybody without the written permission of Architect.

CLIENT:	M/S CREAM STONE
PROJECT/LOCATION:	CREAM STONE, DSHA @HYD AIRPORT

 

TITLE:	SLD LAYOUT
DRAWN:	RACHANA
DATE:	07-03-2024
SCALE:	NOT TO SCALE

ARCHITECTS
SAMRAT ASSOCIATES
 Architecture | Interior | Project Management
 Khajaguda, Prashant Hills
 Hyderabad.
 040-23311009
 E mail: samratarchitects@gmail.com

FF 45 CS @ AIRPORT LOAD CALCULATION

Areas	Lighting, Power, HVAC
POWER SOCKETS	
16A SOCKETS	4.00
6A SOCKETS	0.60
LIGHTING LOAD & SINAGE	1.00
Total Load in KW	5.60
Over all DF	0.70
Total Load in KW	3.9

NOTE

1. All dimensions are in mm, unless specified.
2. Do not scale this drawing, only written dimensions need to be followed.
3. Any discrepancy in the drawing, to be brought to the notice of Architect.

The copy rights of this document is with SAMRAT ASSOCIATES, and it shouldn't be used by anybody without the written permission of Architect.

CLIENT:

M/S CREAM STONE

PROJECT/LOCATION:

CREAM STONE, DSHA
@HYD AIRPORT



TITLE:

ELECTRICAL LOAD SHEET

DRAWN: BUSHRA

DATE: 08-04-2024

SCALE : NOT TO SCALE

ARCHITECTS

SAMRAT ASSOCIATES

Architecture | Interiors | Project Management

Khajaguda, Prashant Hills

Hyderabad.

040-23311009

E mail: samratarchitects@gmail.com

LIGHTING LUX LEVEL CALCULATION

SNO	AREA IN Sqft	AREA Sqmt	LUX LEVEL	UF	MF	LUMEN OUTPUT	NO OF LIGHTS
1	110.5	10.27	1300	0.7	0.7	3000	9.08
AS PER LIGHTING DESING 1300 LUX LEVEL ARRIVED							9NO

NOTE

1. All dimensions are in mm, unless specified.
2. Do not scale this drawing, only written dimensions need to be followed.
3. Any discrepancy in the drawing, to be brought to the notice of Architect.


The copy rights of this document is with SAMRAT ASSOCIATES, and it shouldn't be used by anybody without the written permission of Architect.

CLIENT:

M/S CREAM STONE

PROJECT/LOCATION:

CREAM STONE, DSHA
@HYD AIRPORT

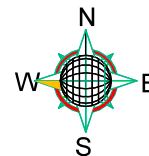

TITLE:

LUX REPORT

DRAWN: BUSHRA

DATE: 08-04-2024

SCALE : NOT TO SCALE

ARCHITECTS

SAMRAT ASSOCIATES

Architecture | interiors | Project Management

Khajaguda, Prashant Hills

Hyderabad.

040-23311009

E mail: samratarchitects@gmail.com