

CODE	DESCRIPTION
C01	COUNTER IN PLY
C02	SCOOP
C03	CASH COUNTER IN PLY
C04	STONE
C05	FRIDGE
C06	COUNTER IN PLY
C07	DOUBLE DOOR FREEZER (DISPLAY)
C08	GRANITE COUNTER IN PLY BASE
C09	FRIDGE
C10	CHILLER+STONE
C11	DRY STORAGE IN S.S
C12	BIN
C13	SINK
C14	SINK
C15	WORKING COUNTER IN S.S

**NOTE**

- All dimensions are in mm, unless specified.
- Do not scale this drawing, only written dimensions need to be followed.
- Any discrepancy in the drawing, to be brought to the notice of Architect.

The copy rights of this document is with SAMRAT ASSOCIATES, and it shouldn't be used by anybody without the written permission of Architect.

**CLIENT:**

M/S CREAM STONE

**PROJECT/LOCATION:**

CREAM STONE, WEST BULB @HYD AIRPORT



**TITLE:**

FLOOR PLAN

DRAWN: BUSHRA

DATE: 08-04-2024

SCALE : NOT TO SCALE


**ARCHITECTS**

**SAMRAT ASSOCIATES**

Architecture | Interiors | Project Management

Khajaguda, Prashant Hills  
Hyderabad,  
040-23311009

E mail: samratarchitects@gmail.com

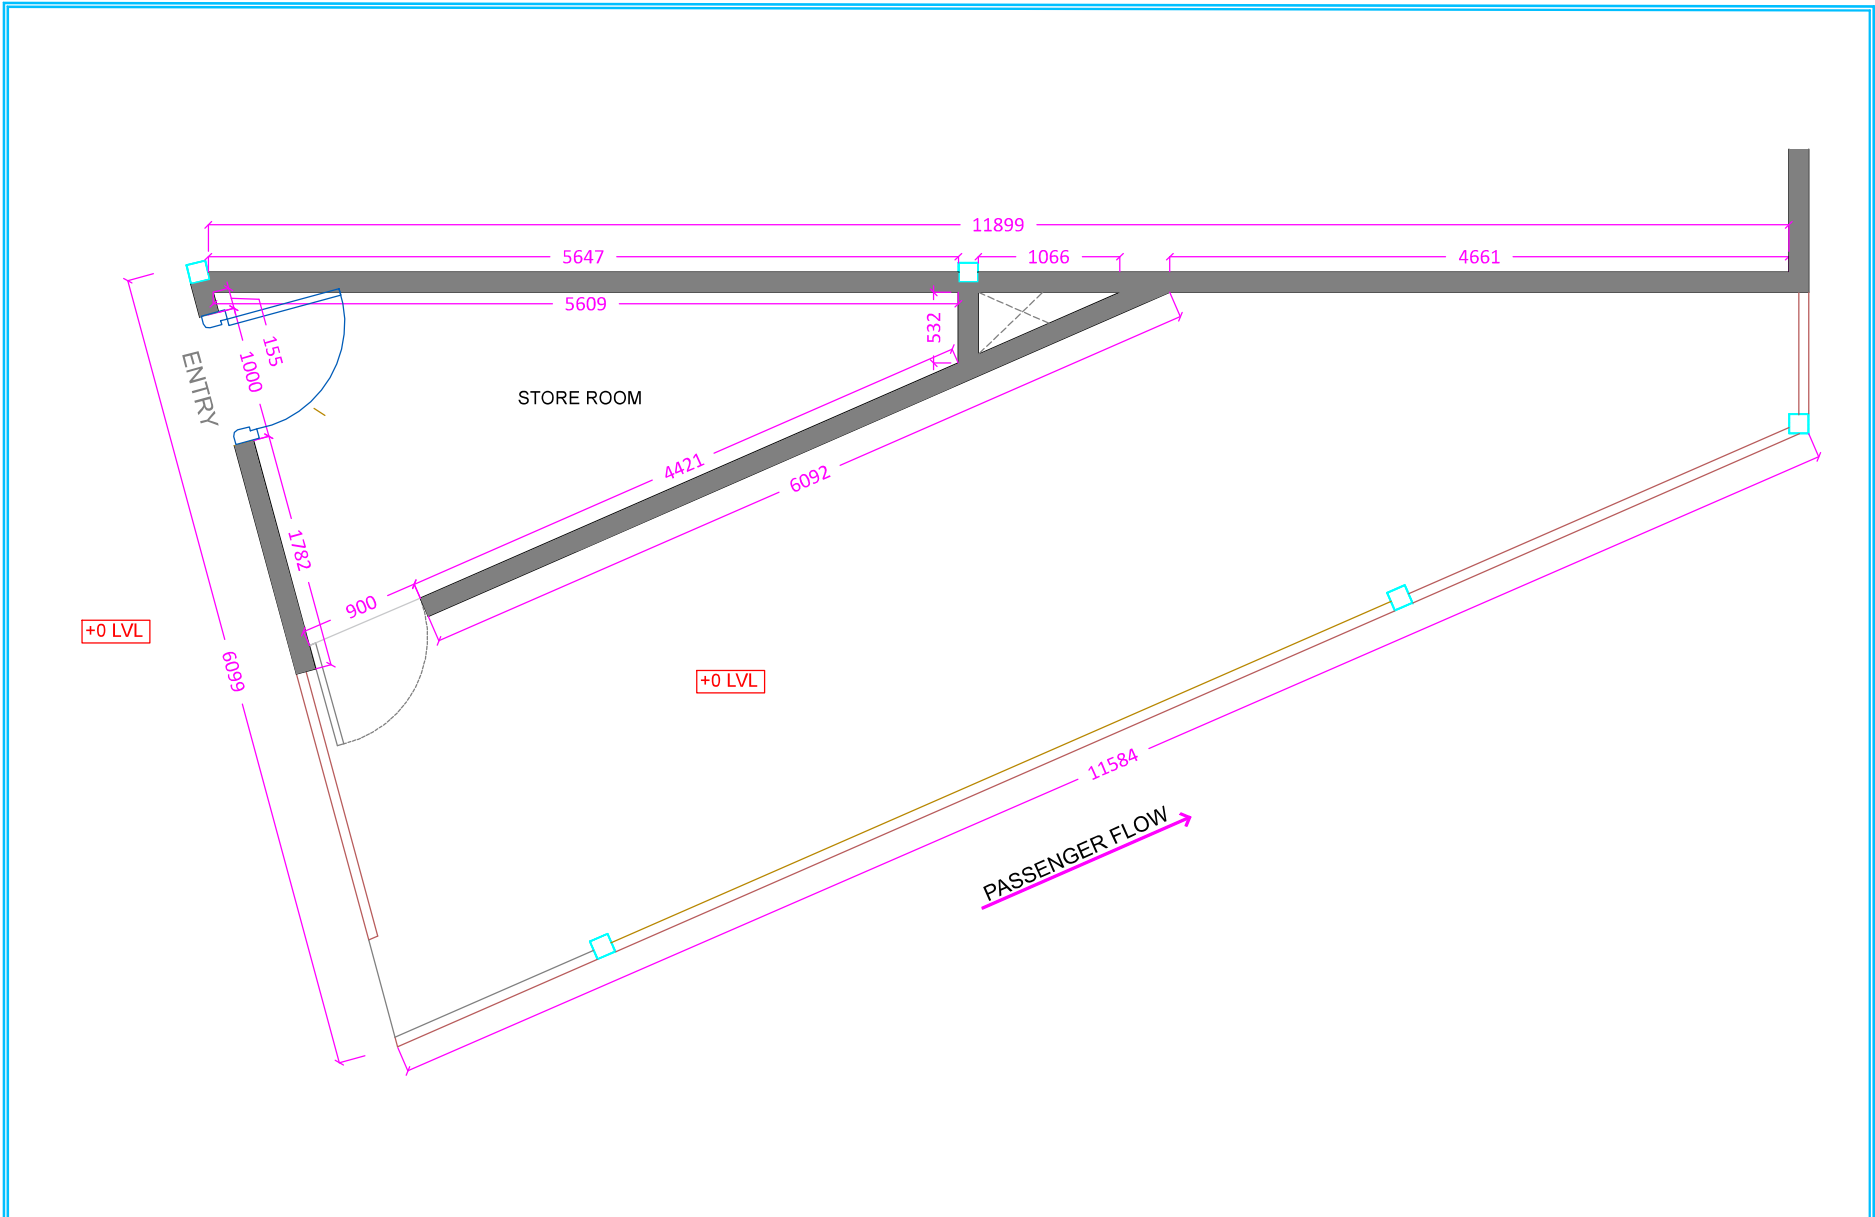

**NOTE**

1. All dimensions are in mm, unless specified.
2. Do not scale this drawing, only written dimensions need to be followed.
3. Any discrepancy in the drawing, to be brought to the notice of Architect.

The copy rights of this document is with SAMRAT ASSOCIATES, and it shouldn't be used by anybody without the written permission of Architect.

**CLIENT:**

M/S CREAM STONE

**PROJECT/LOCATION:**

CREAM STONE, WEST BULB @HYD AIRPORT



**TITLE:**

CIVIL PLAN

DRAWN: BUSHRA

DATE: 08-04-2024

SCALE :

NOT TO SCALE


**ARCHITECTS**

**SAMRAT ASSOCIATES**

Architecture | interiors | Project Management

Khajaguda, Prashant Hills  
Hyderabad,  
040-23311009

E mail: samratarchitects@gmail.com

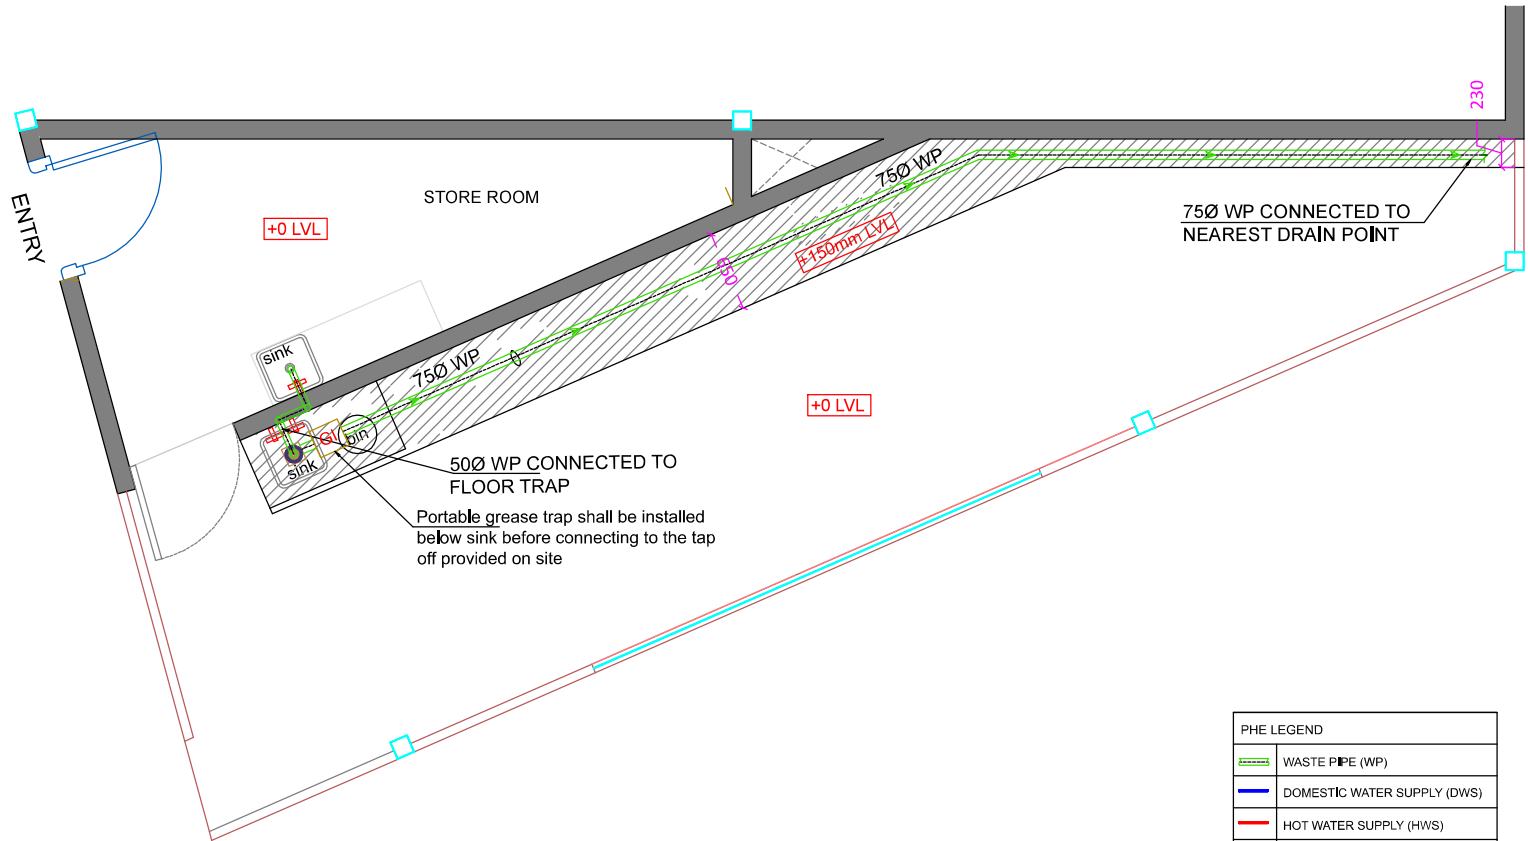

PHE LEGEND	
	WASTE PIPE (WP)
	DOMESTIC WATER SUPPLY (DWS)
	HOT WATER SUPPLY (HWS)
	FLOOR TRAP (FT)
	DROP
	GREASE TRAP

**NOTE**


1. All dimensions are in mm, unless specified.
2. Do not scale this drawing, only written dimensions need to be followed.
3. Any discrepancy in the drawing, to be brought to the notice of Architect.

The copy rights of this document is with SAMRAT ASSOCIATES, and it shouldn't be used by anybody without the written permission of Architect.

CLIENT:  
**M/S CREAM STONE**

---

PROJECT/LOCATION:  
**CREAM STONE, WEST BULB @HYD AIRPORT**

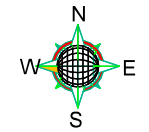

TITLE:  
**DRAINAGE PLUMBING LAYOUT**


DRAWN: BUSHRA

DATE: 08-04-2024

SCALE :  
 NOT TO SCALE

ARCHITECTS  
**SAMRAT ASSOCIATES**  
 Architecture | interiors | Project Management

Khajaguda, Prashant Hills  
 Hyderabad.  
 040-23311009  
 E. mail: samratarchitects@gmail.com

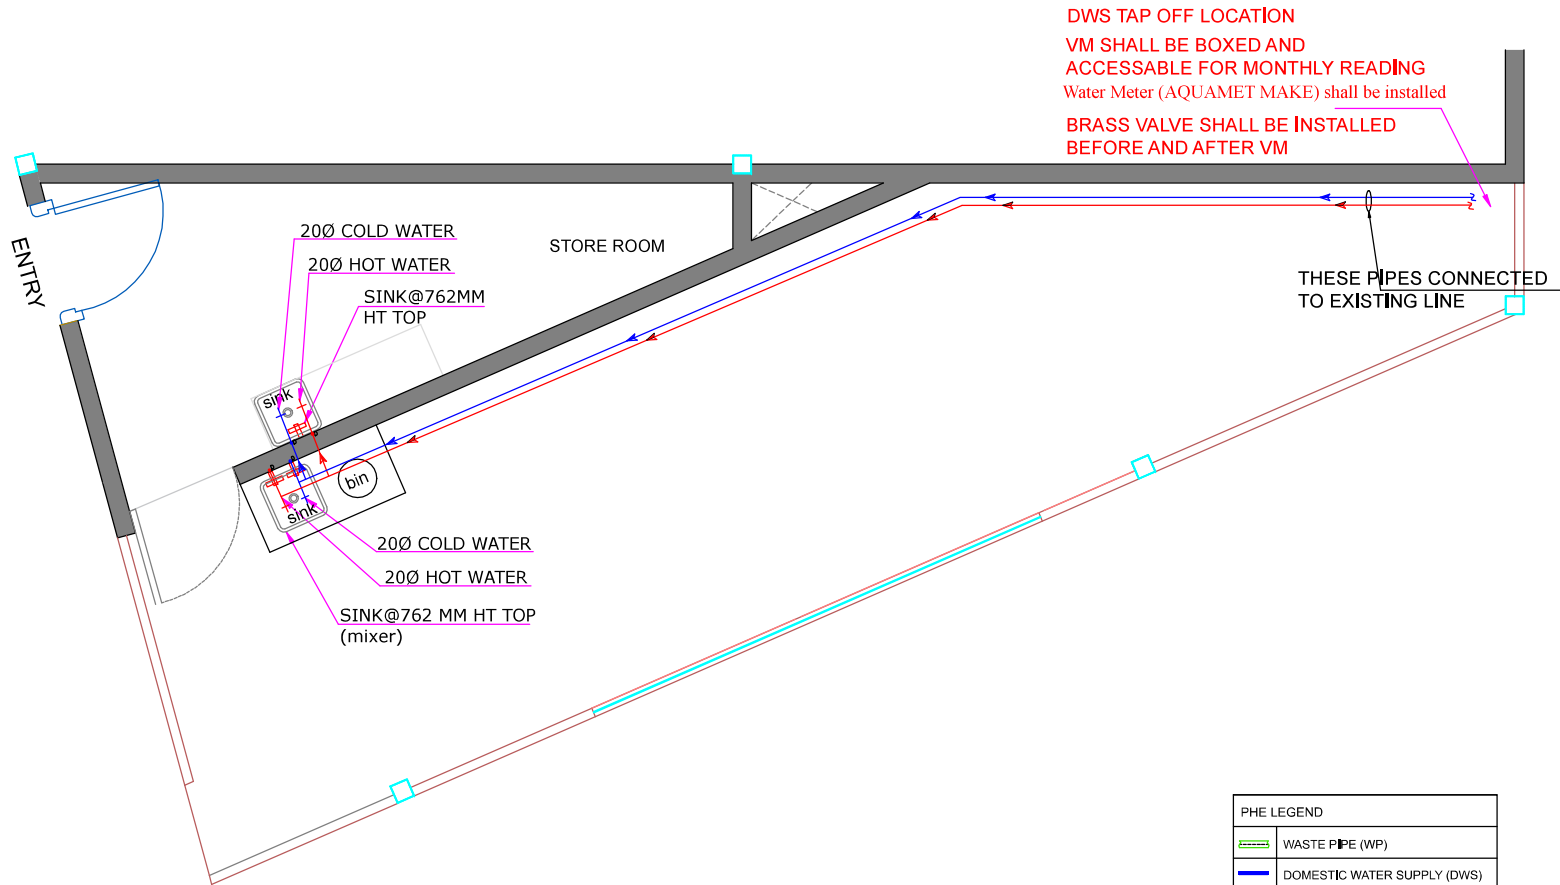

+0 LVL

DWS TAP OFF LOCATION  
 VM SHALL BE BOXED AND  
 ACCESSIBLE FOR MONTHLY READING  
 Water Meter (AQUAMET MAKE) shall be installed  
 BRASS VALVE SHALL BE INSTALLED  
 BEFORE AND AFTER VM

THESE PIPES CONNECTED  
 TO EXISTING LINE

PHE LEGEND	
	WASTE PIPE (WP)
	DOMESTIC WATER SUPPLY (DWS)
	HOT WATER SUPPLY (HWS)
	FLOOR TRAP (FT)
	DROP

**NOTE**

1. All dimensions are in mm, unless specified.
2. Do not scale this drawing, only written dimensions need to be followed.
3. Any discrepancy in the drawing, to be brought to the notice of Architect.


The copy rights of this document is with SAMRAT ASSOCIATES, and it shouldn't be used by anybody without the written permission of Architect.

**CLIENT:**

M/S CREAM STONE

**PROJECT/LOCATION:**

CREAM STONE, WEST BULB  
 @HYD AIRPORT

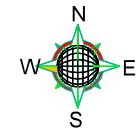

**TITLE:**

WATER SUPPLY  
 PLUMBING LAYOUT

**DRAWN:** BUSHRA

**DATE:** 07-03-2024

**SCALE :**


NOT TO SCALE

**ARCHITECTS**  
**SAMRAT ASSOCIATES**

Architecture | interiors | Project Management

Khajaguda, Prashant Hills  
 Hyderabad,  
 040-23311009

E mail: samratarchitects@gmail.com

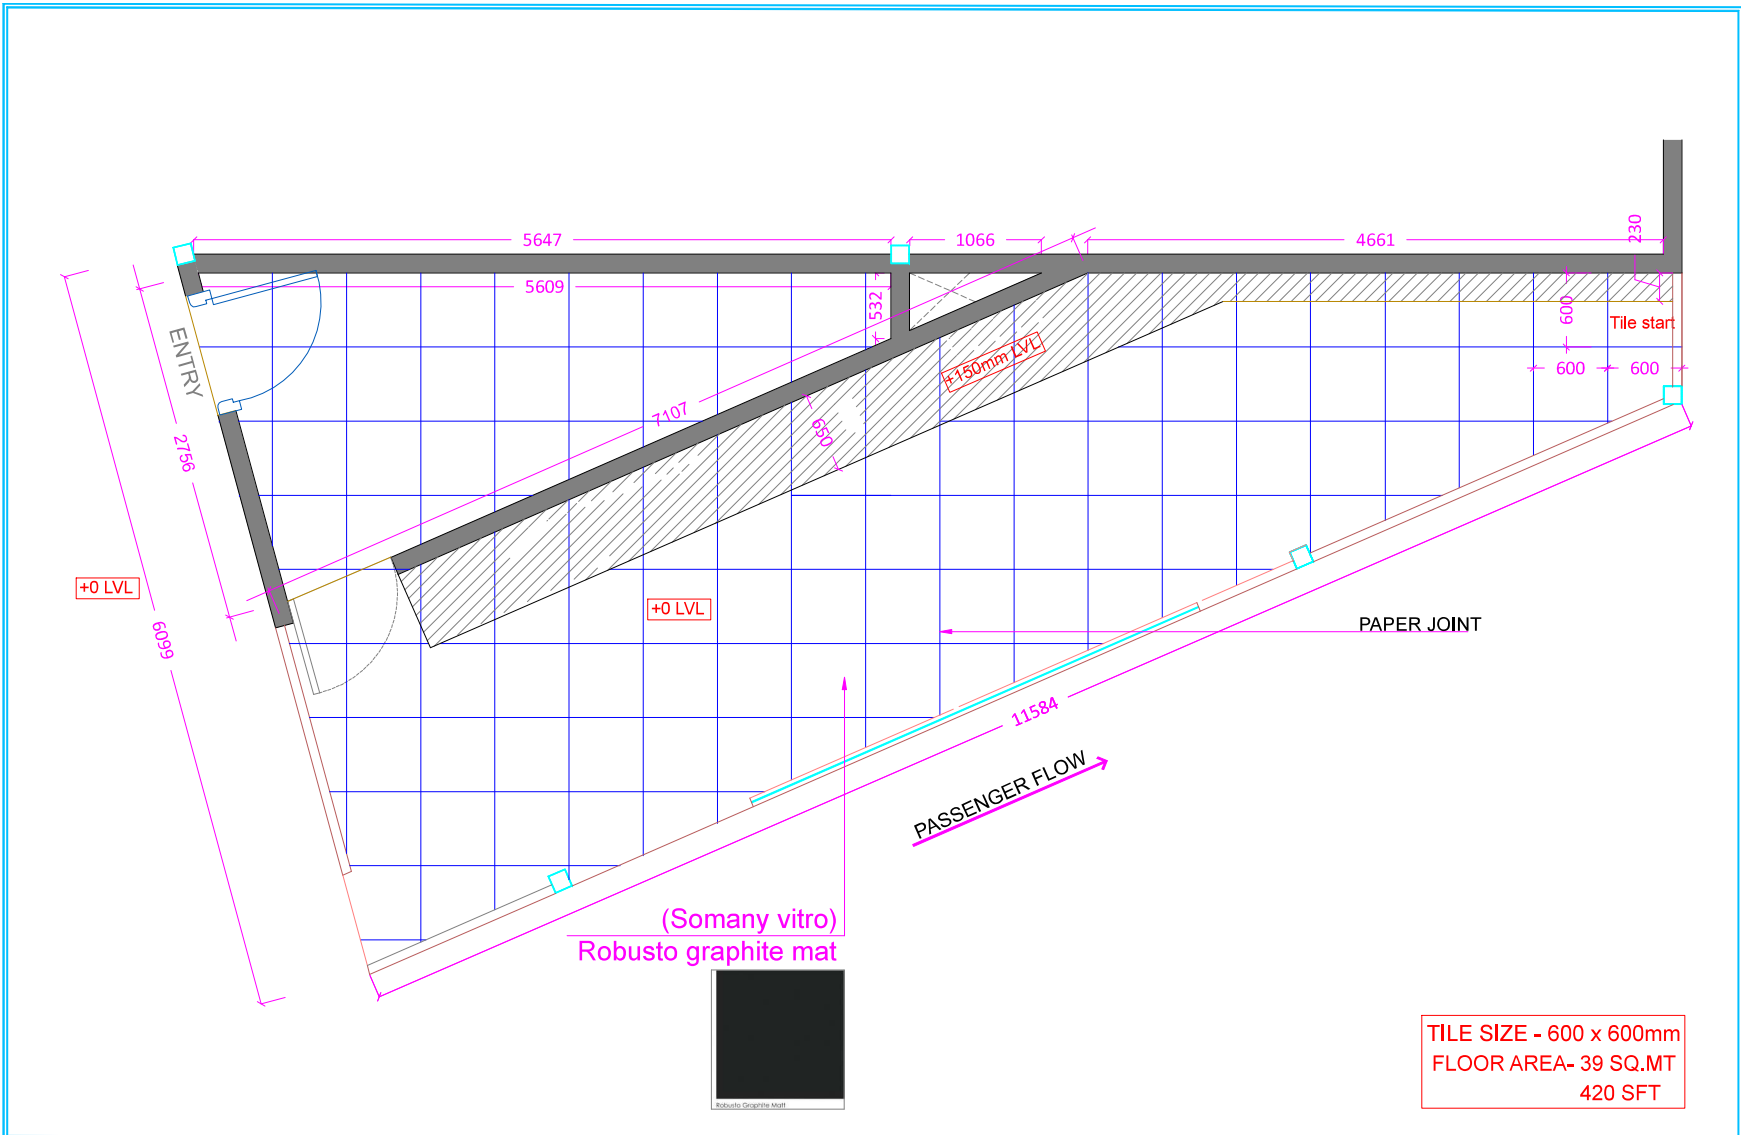

**NOTE**

1. All dimensions are in mm, unless specified.
2. Do not scale this drawing, only written dimensions need to be followed.
3. Any discrepancy in the drawing, to be brought to the notice of Architect.


The copy rights of this document is with SAMRAT ASSOCIATES, and it shouldn't be used by anybody without the written permission of Architect.

**CLIENT:**

**M/S CREAM STONE**

**PROJECT/LOCATION:**

**CREAM STONE, WEST BULB  
@HYD AIRPORT**

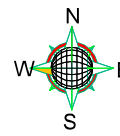

**TITLE:**

**FLOORING**

**DRAWN: BUSHRA**

**DATE: 07-03-2024**

**SCALE :**

**NOT TO SCALE**

**ARCHITECTS**

**SAMRAT ASSOCIATES**


Architecture | interiors | Project Management

Khajaguda, Prashant Hills

Hyderabad.

040-23311009

E mail: samratarchitects@gmail.com

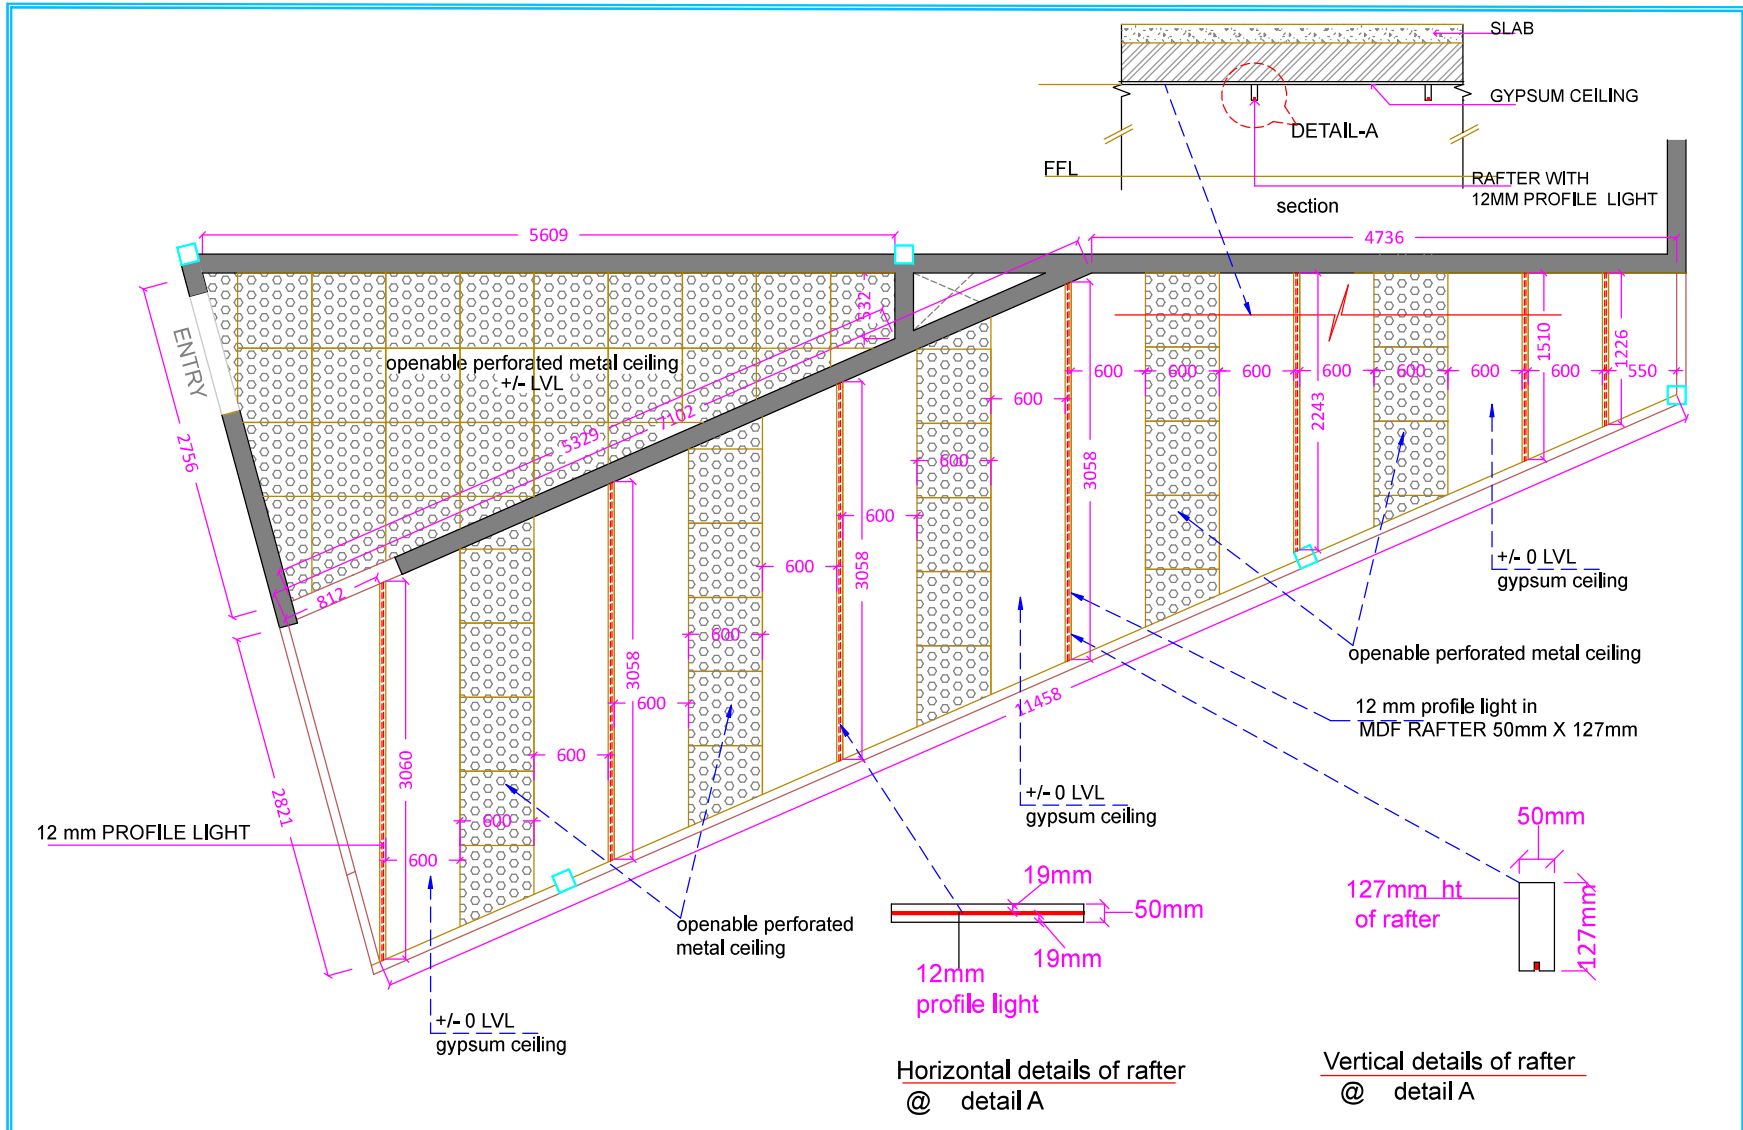

**NOTE**


1. All dimensions are in mm, unless specified.
2. Do not scale this drawing, only written dimensions need to be followed.
3. Any discrepancy in the drawing, to be brought to the notice of Architect.

The copy rights of this document is with SAMRAT ASSOCIATES, and it shouldn't be used by anybody without the written permission of Architect.

CLIENT:  
M/S CREAM STONE

---

PROJECT/LOCATION:  
CREAM STONE, WEST BULB  
@HYD AIRPORT

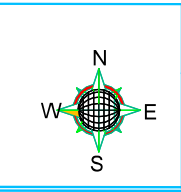

TITLE:  
CEILING LAYOUT

---

DRAWN: BUSHRA

---



DATE: 07-04-2024

---

SCALE:  
NOT TO SCALE

ARCHITECTS  
SAMRAT ASSOCIATES  
Architecture | interiors | Project Management

Khajaguda, Prashant Hills  
Hyderabad.  
040-23311009  
E mail: samratarchitects@gmail.com

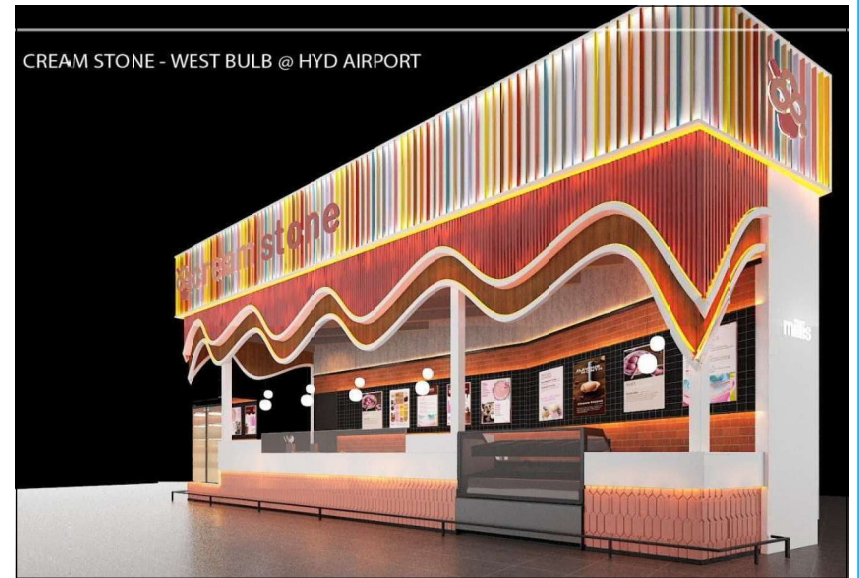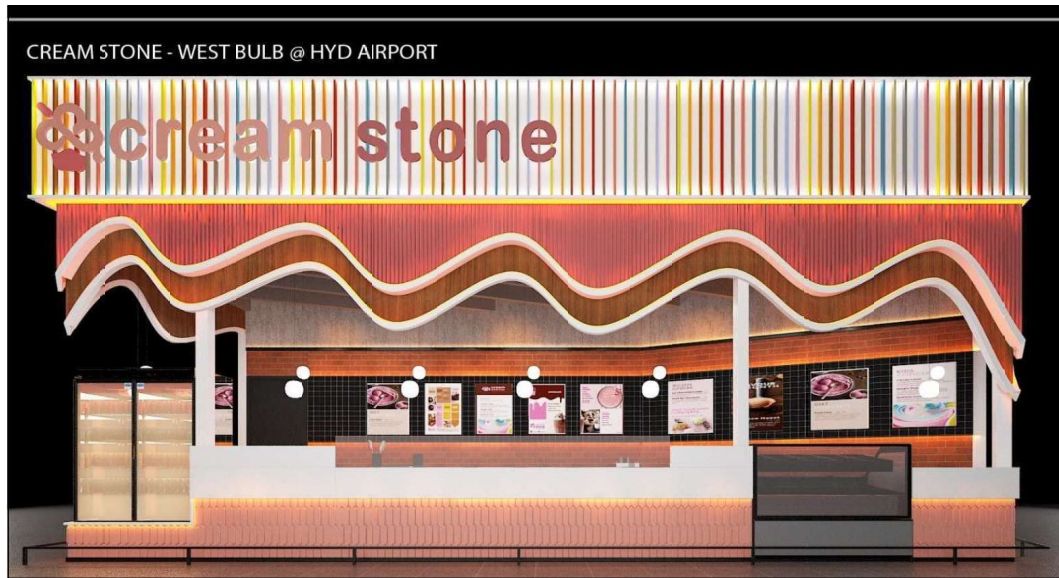

**NOTE**

1. All dimensions are in mm, unless specified.
2. Do not scale this drawing, only written dimensions need to be followed.
3. Any discrepancy in the drawing, to be brought to the notice of Architect.

The copy rights of this document is with SAMRAT ASSOCIATES, and it shouldn't be used by anybody without the written permission of Architect.

**CLIENT:**

M/S CREAM STONE

**PROJECT/LOCATION:**

CREAM STONE, WEST BULB @HYD AIRPORT



**TITLE:**

IEWS

DRAWN: BUSHRA

DATE: 08-04-2024

SCALE : NOT TO SCALE

**ARCHITECTS**

**SAMRAT ASSOCIATES**


Architecture | interiors | Project Management

Khajaguda, Prashant Hills


Hyderabad.

040-23311009

e mail: samratarchitects@gmail.com

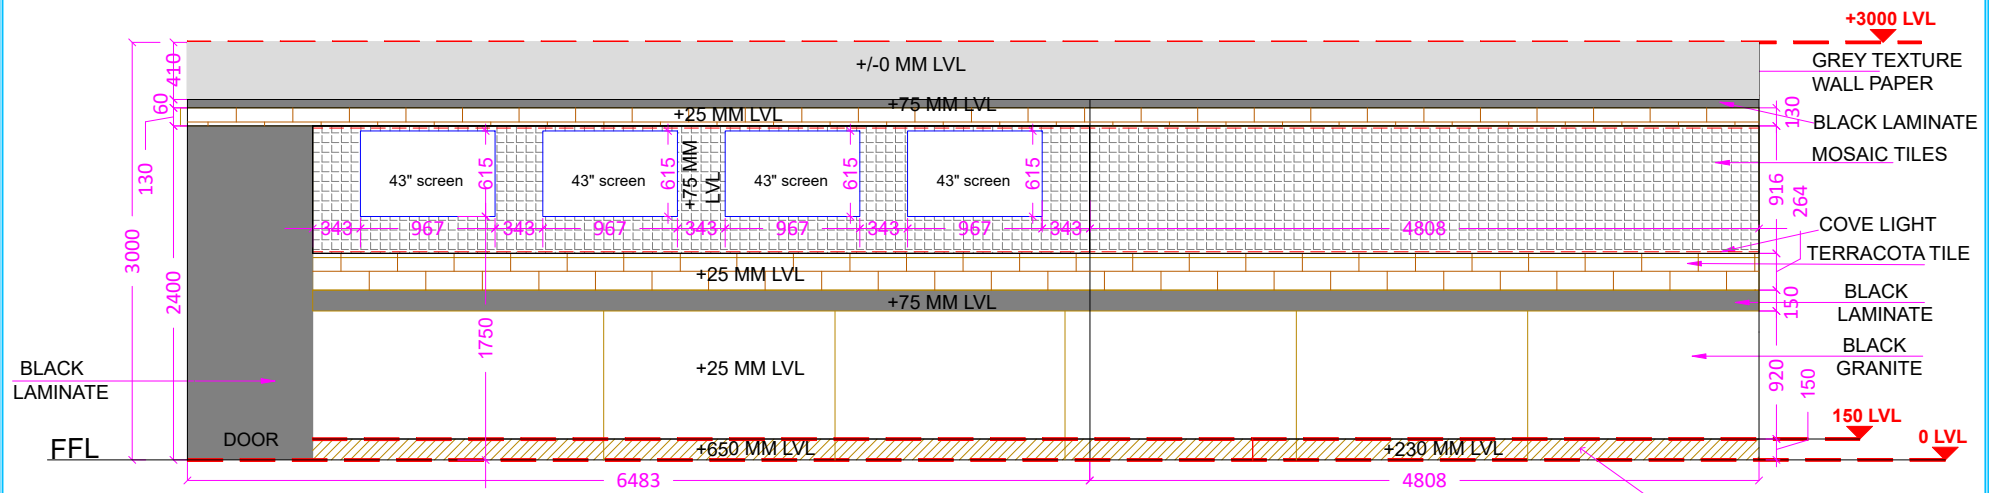

**INTERIOR WALL ELEVATION**

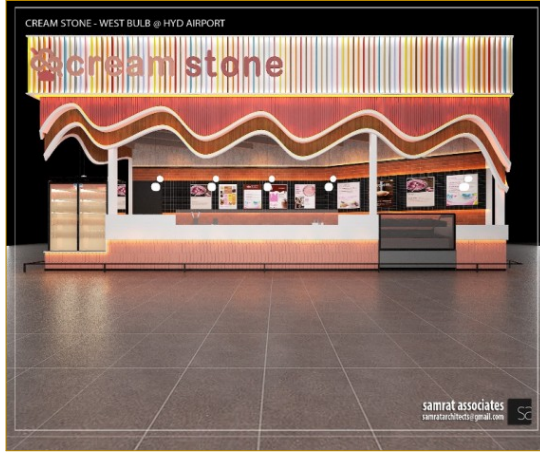


**NOTE**  
 1. All dimensions are in mm, unless specified.  
 2. Do not scale this drawing, only written dimensions need to be followed.  
 3. Any discrepancy in the drawing, to be brought to the notice of Architect.

The copy rights of this document is with SAMRAT ASSOCIATES, and it shouldn't be used by anybody without the written permission of Architect.

**CLIENT:**  
 M/S CREAM STONE

 **PROJECT/LOCATION:**  
 CREAM STONE, WEST BULB @HYD AIRPORT



**TITLE:**  
 INTERIOR WALL ELEVATION




**DRAWN:** BUSHRA

**DATE:** 08-04-2024


**SCALE :** NOT TO SCALE

**ARCHITECTS**  
**SAMRAT ASSOCIATES**  
 Architecture | interiors | Project Management  
 Khajaguda, Prashant Hills  
 Hyderabad.  
 040-23311009  
 e mail: samratarchitects@gmail.com



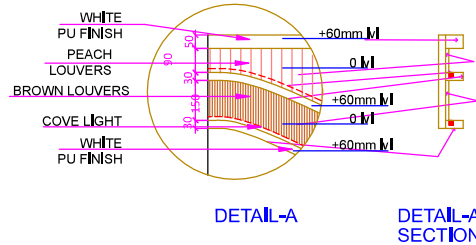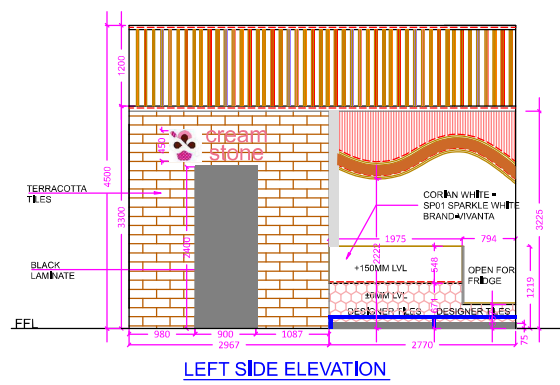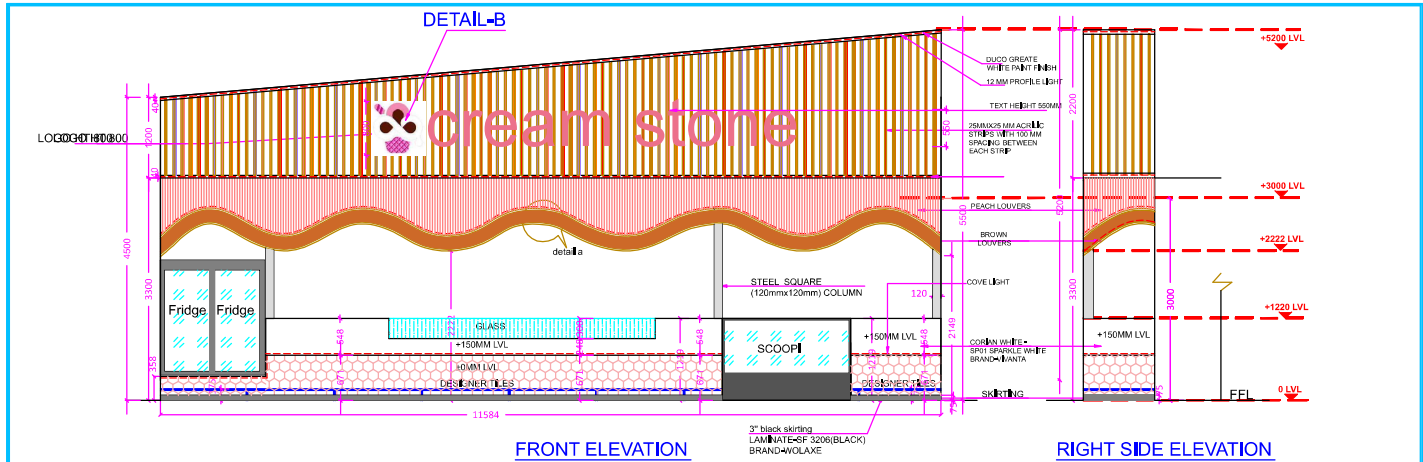

<p><b>NOTE</b></p> <p>1. All dimensions are in mm, unless specified.</p> <p>2. Do not scale this drawing, only written dimensions need to be followed.</p> <p>3. Any discrepancy in the drawing, to be brought to the notice of Architect.</p> <p>The copy rights of this document is with SAMRAT ASSOCIATES, and it shouldn't be used by anybody without the written permission of Architect.</p>	<p><b>CLIENT:</b></p> <p>M/S CREAM STONE</p>		<p><b>TITLE:</b></p> <p>EXTERIOR ELEVATION SIGNAGE</p>	<p><b>ARCHITECTS</b></p> <p><b>SAMRAT ASSOCIATES</b>          Architecture   Interior   Project Management          Khajaguda Prashant Hills          Hyderabad,          040-23311009          e mail: samratarchitects@gmail.com</p>
	<p><b>PROJECT/LOCATION:</b></p> <p>CREAM STONE, WEST BULB @HYD AIRPORT</p>		<p><b>DRAWN:</b> BUSHRA</p>	
			<p><b>DATE:</b> 07-03-2024</p> <p><b>SCALE:</b> NOT TO SCALE</p>	

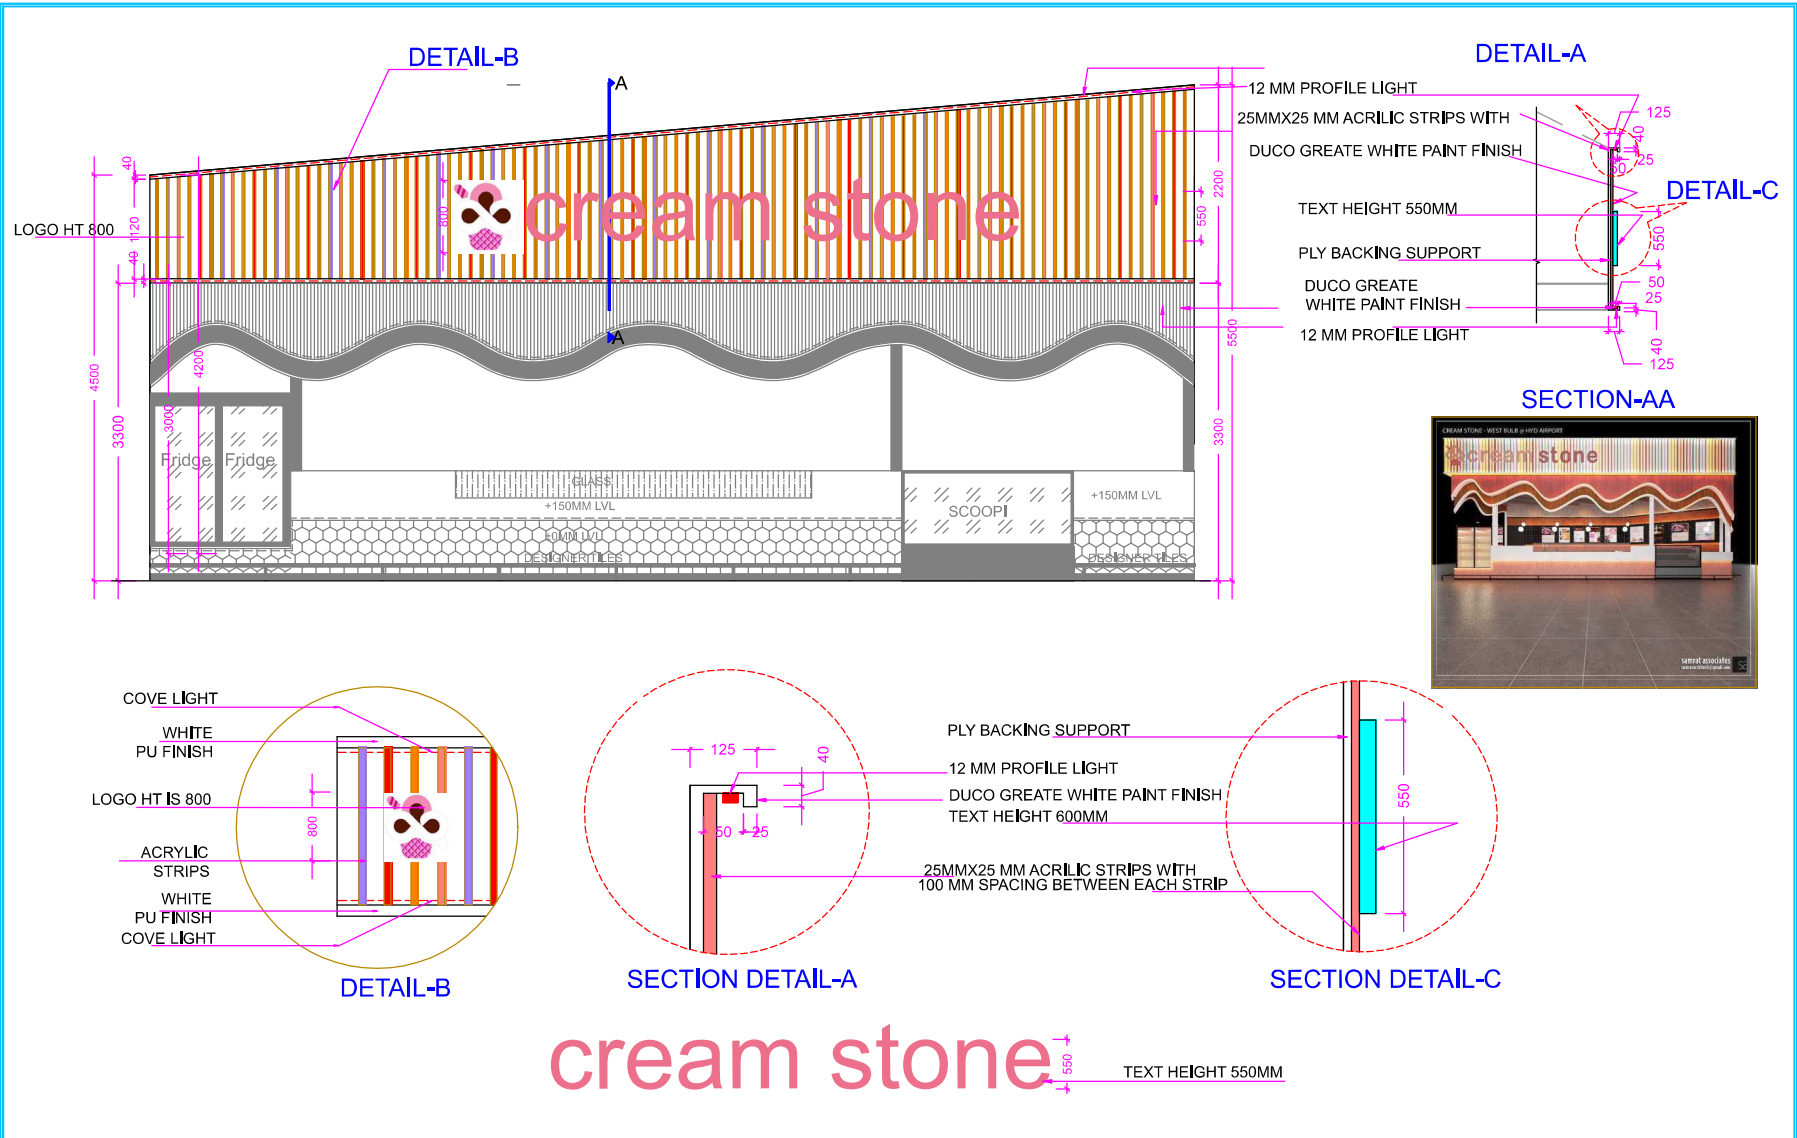

**NOTE**

1. All dimensions are in mm, unless specified.
2. Do not scale this drawing, only written dimensions need to be followed.
3. Any discrepancy in the drawing, to be brought to the notice of Architect.

The copy rights of this document is with SAMRAT ASSOCIATES, and it shouldn't be used by anybody without the written permission of Architect.

**CLIENT:**  
M/S CREAM STONE

**PROJECT/LOCATION:**  
CREAM STONE, WEST BULB @HYD AIRPORT

**TITLE:**  
BULK HEAD WITH SIGNAGE DETAIL



**DRAWN:** BUSHRA

**DATE:** 08-04-2024

**SCALE :** NOT TO SCALE

**ARCHITECTS**  
**SAMRAT ASSOCIATES**  
Architecture | interiors | Project Management

Khajaguda, Prashant Hills  
Hyderabad.  
040-23311009  
e mail: samratarchitects@gmail.com

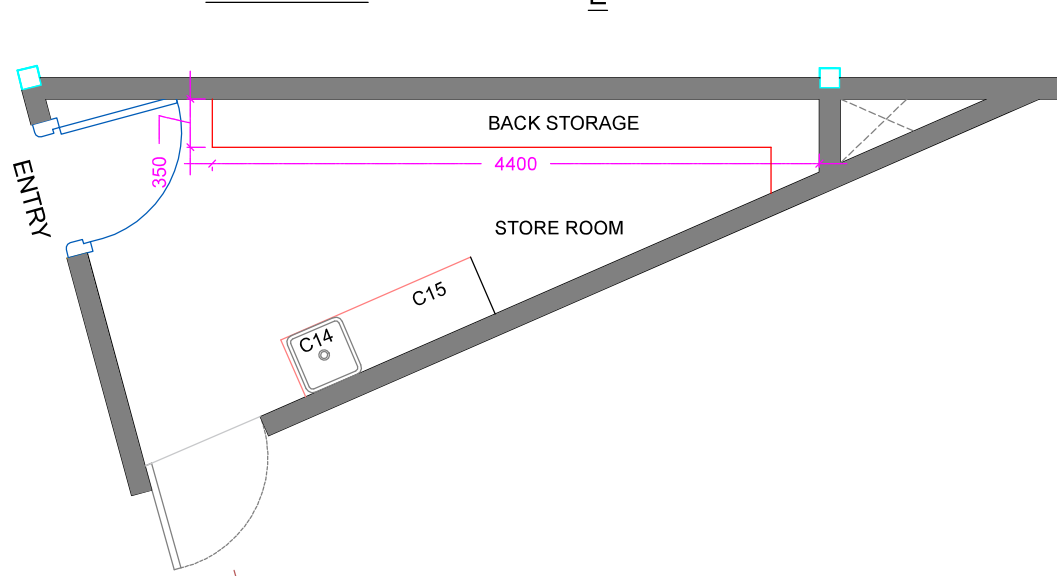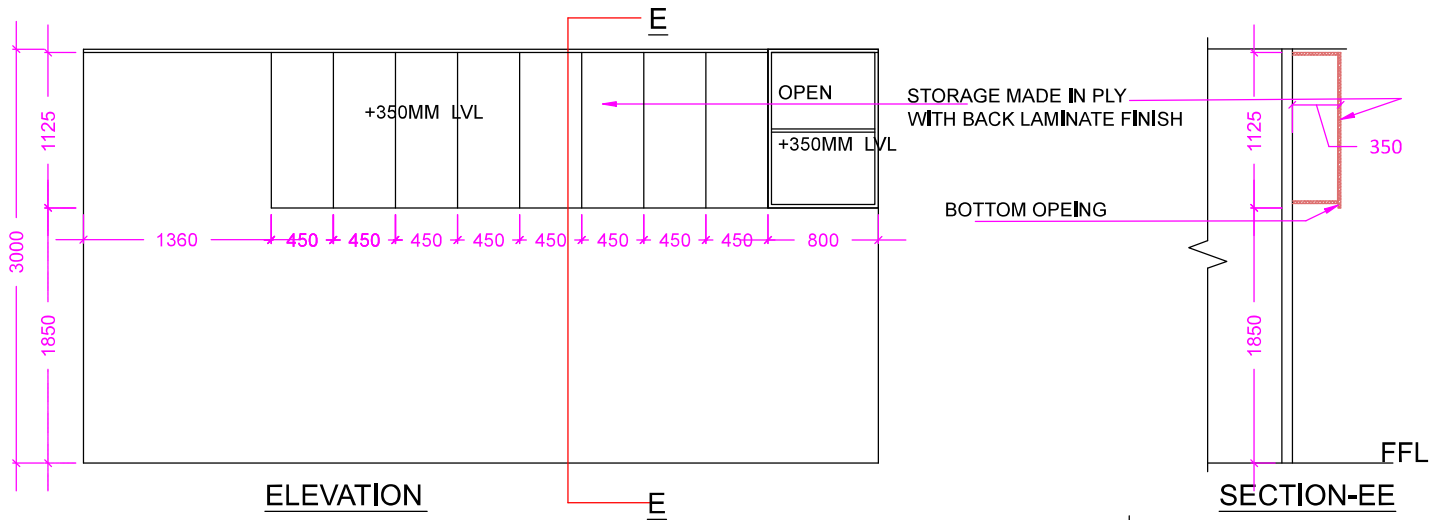

**NOTE**

1. All dimensions are in mm, unless specified.
2. Do not scale this drawing, only written dimensions need to be followed.
3. Any discrepancy in the drawing, to be brought to the notice of Architect.

The copy rights of this document is with SAMRAT ASSOCIATES, and it shouldn't be used by anybody without the written permission of Architect.

**CLIENT:**

M/S CREAM STONE

**PROJECT/LOCATION:**

CREAM STONE, WEST BULB @HYD AIRPORT



**TITLE:**

INTERIOR WALL ELEVATION

DRAWN: BUSHRA

DATE: 07-03-2024

SCALE : NOT TO SCALE

**ARCHITECTS**

**SAMRAT ASSOCIATES**


Architecture | Interiors | Project Management

Khajaguda, Prashant Hills


Hyderabad.

040-23311009


e mail: samratarchitects@gmail.com

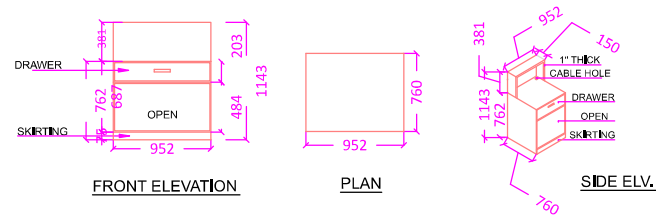


CASH COUNTER

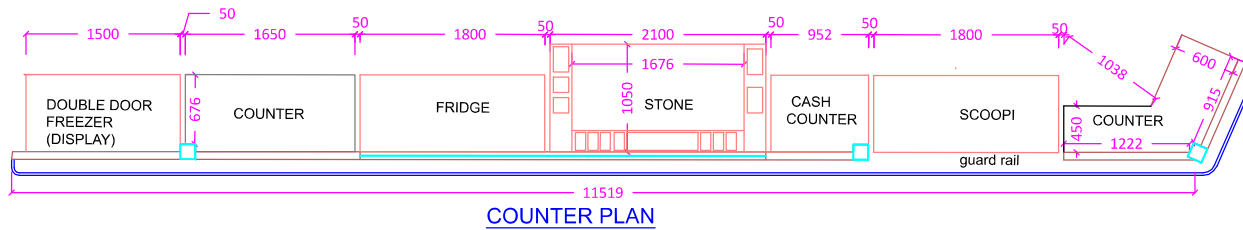


COUNTER PLAN

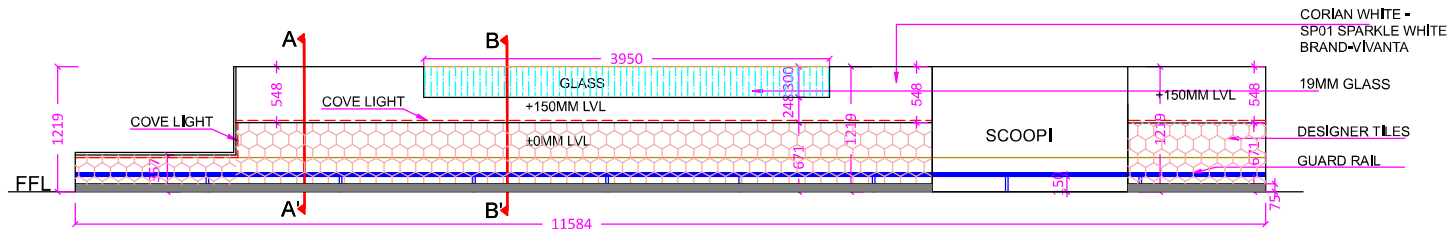

COUNTER FRONT ELEVATION

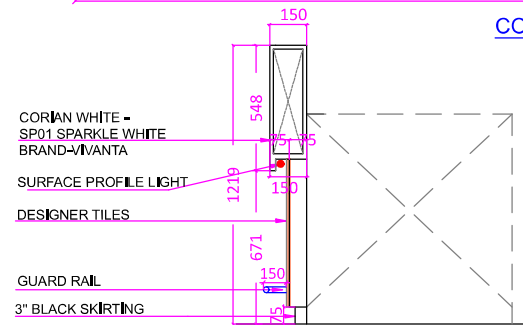

SECTION-AA'

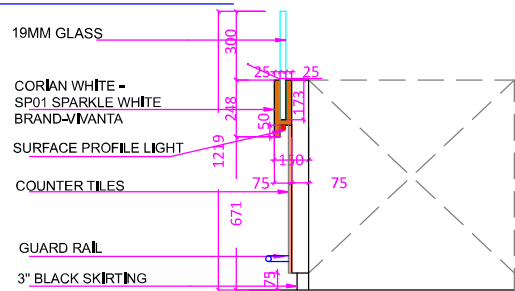

SECTION-BB'

NOTE

1. All dimensions are in mm, unless specified.
2. Do not scale this drawing, only written dimensions need to be followed.
3. Any discrepancy in the drawing, to be brought to the notice of Architect.

The copy rights of this document is with SAMRAT ASSOCIATES, and it shouldn't be used by anybody without the written permission of Architect.

CLIENT:

M/S CREAM STONE

PROJECT/LOCATION:

CREAM STONE, WEST BULB @HYD AIRPORT



TITLE:

COUNTER DETAILS

DRAWN: BUSHRA

DATE: 07-03-2024

SCALE: NOT TO SCALE

ARCHITECTS

SAMRAT ASSOCIATES


Architecture | Interiors | Project Management

Khajaguda, Prashant Hills

Hyderabad,

040-23311009

e mail: samratarchitects@gmail.com

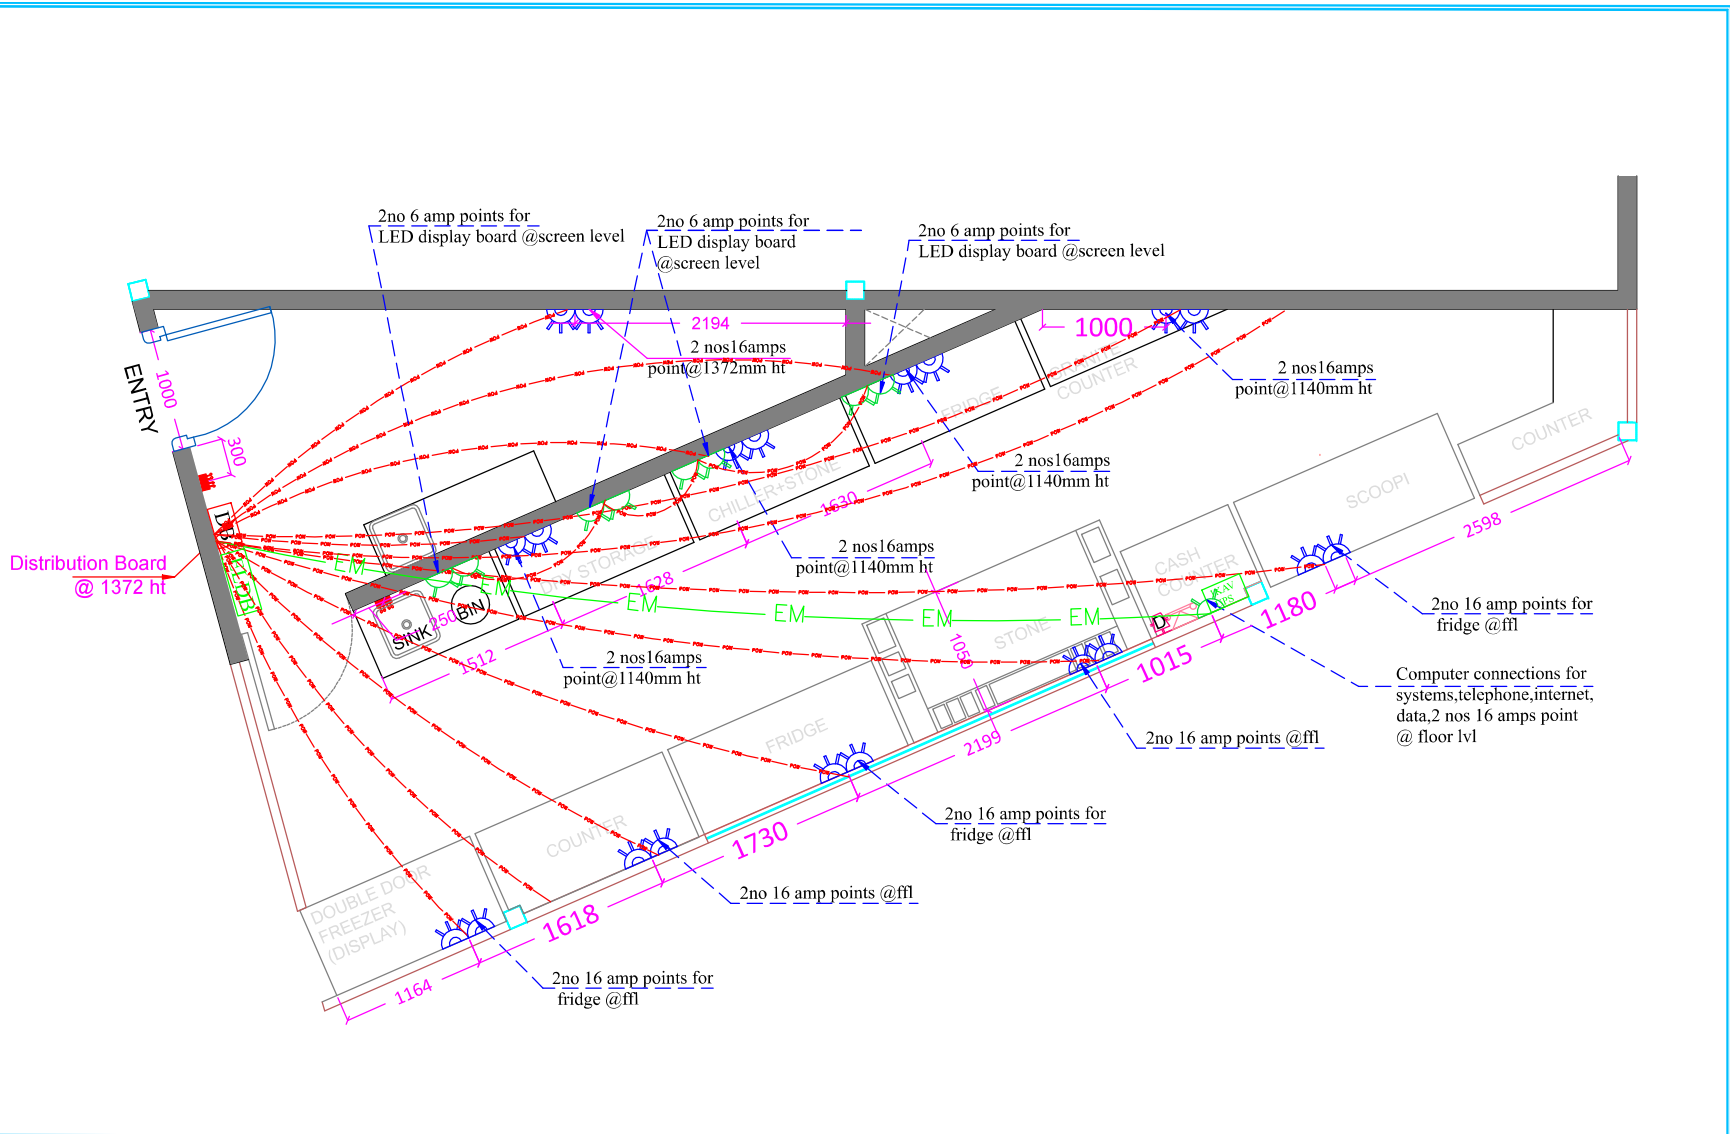

**NOTE**

- 1. All dimensions are in mm, unless specified.
- 2. Do not scale this drawing, only written dimensions need to be followed.
- 3. Any discrepancy in the drawing, to be brought to the notice of Architect.


The copy rights of this document is with SAMRAT ASSOCIATES, and it shouldn't be used by anybody without the written permission of Architect.

**CLIENT:**

M/S CREAM STONE

**PROJECT/LOCATION:**

CREAM STONE, WEST BULB @HYD AIRPORT

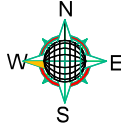

**TITLE:**

POWER LOOPING PLAN

DRAWN: BUSHRA

DATE: 09-04-2024

SCALE : NOT TO SCALE

**ARCHITECTS**  
**SAMRAT ASSOCIATES**


Architecture | interiors | Project Management

Khajaguda, Prashant Hills

Hyderabad.

040-23311009

E. mail: samratarchitects@gmail.com

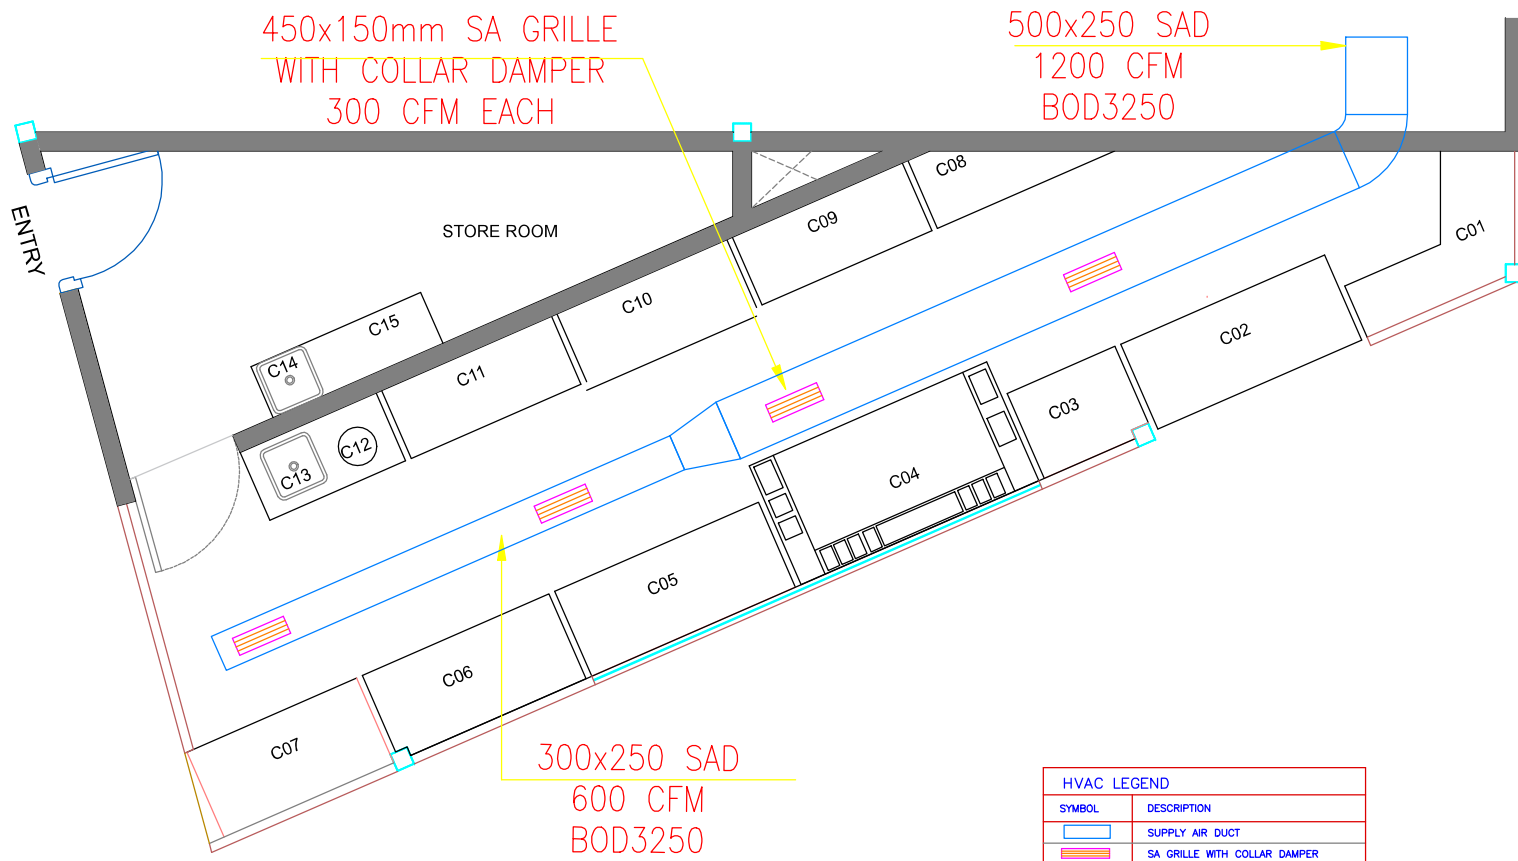

HVAC LEGEND	
SYMBOL	DESCRIPTION
	SUPPLY AIR DUCT
	SA GRILLE WITH COLLAR DAMPER

**NOTE**

1. All dimensions are in mm, unless specified.
2. Do not scale this drawing, only written dimensions need to be followed.
3. Any discrepancy in the drawing, to be brought to the notice of Architect.

The copy rights of this document is with SAMRAT ASSOCIATES, and it shouldn't be used by anybody without the written permission of Architect.

CLIENT:  
**M/S CREAM STONE**

---

PROJECT/LOCATION:  
**CREAM STONE, WEST BULB @HYD AIRPORT**



TITLE:  
**HVAC LAYOUT**

---

DRAWN: BUSHRA

---

DATE: 07-04-2024


---

SCALE :  
 NOT TO SCALE

ARCHITECTS  
**SAMRAT ASSOCIATES**  
 Architecture | interiors | Project Management

Khajaguda, Prashant Hills  
 Hyderabad,  
 040-23311009  
 E. mail: samratarchitects@gmail.com



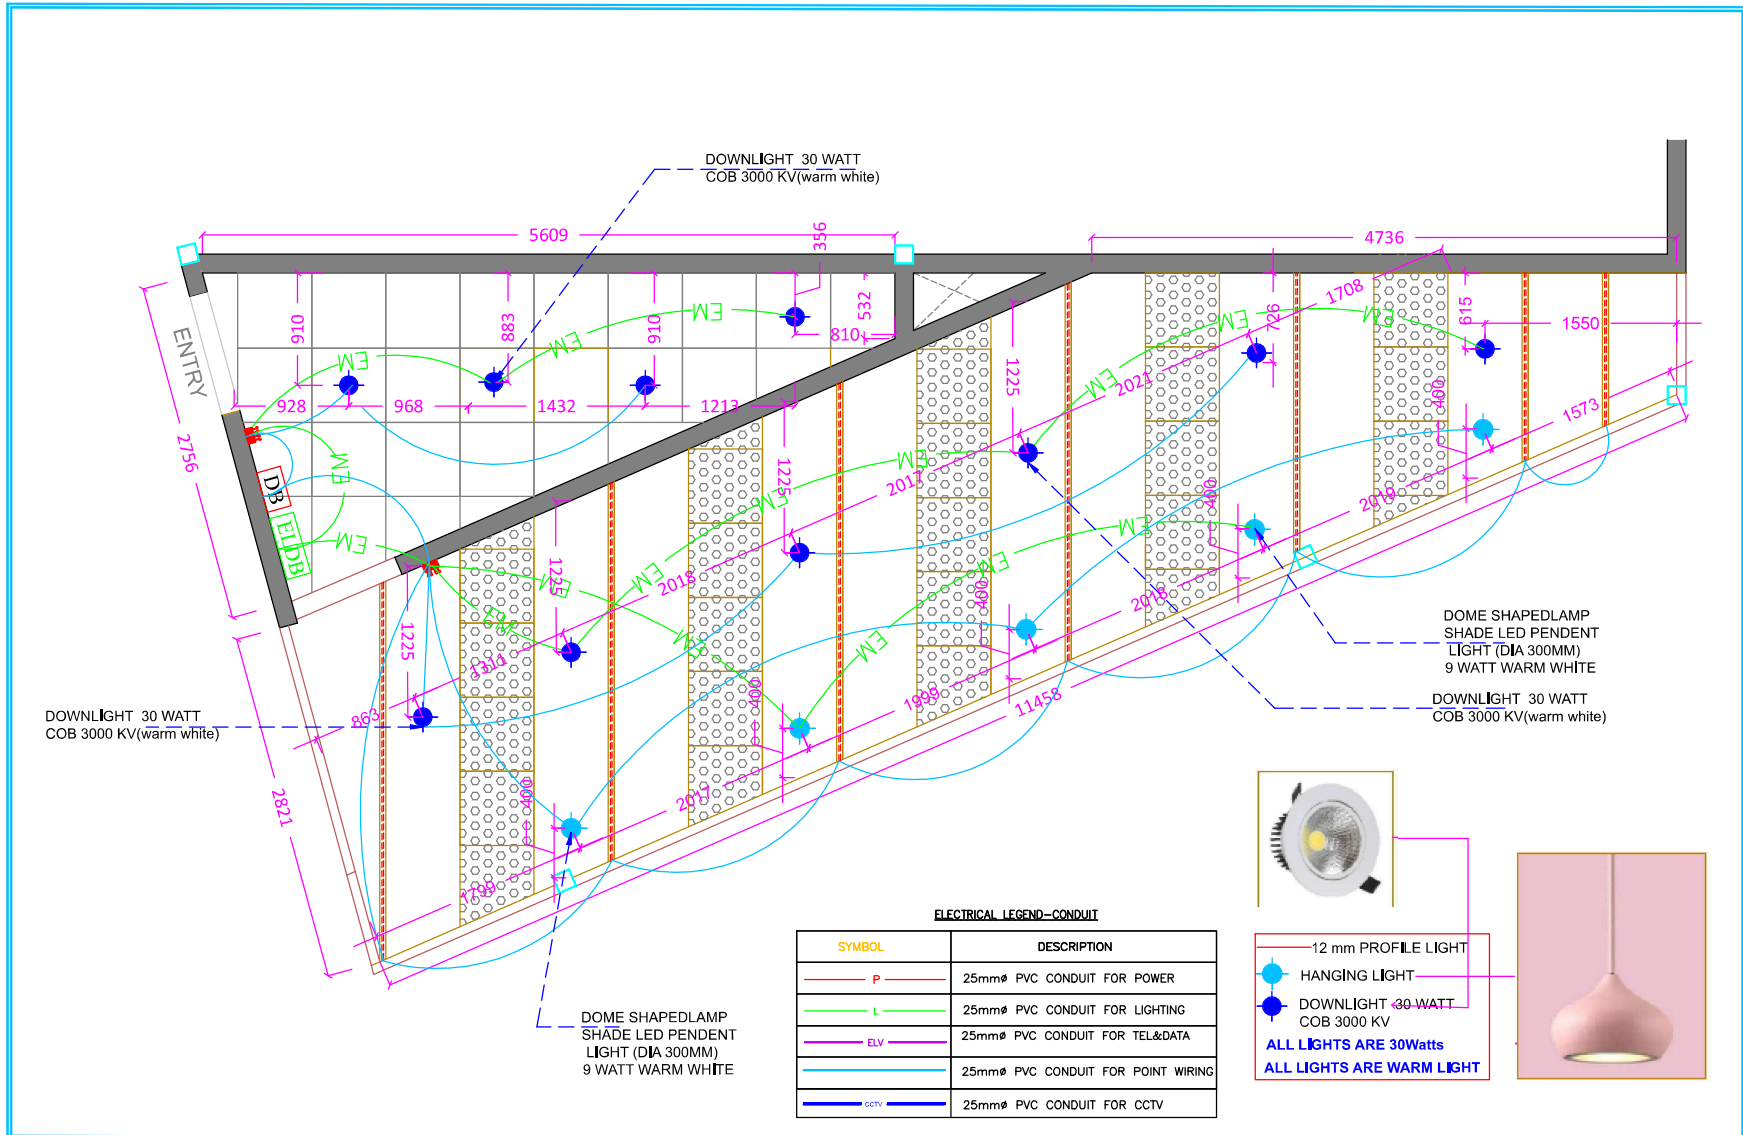

**NOTE**

1. All dimensions are in mm, unless specified.
2. Do not scale this drawing, only written dimensions need to be followed.
3. Any discrepancy in the drawing, to be brought to the notice of Architect.


The copy rights of this document is with SAMRAT ASSOCIATES, and it shouldn't be used by anybody without the written permission of Architect.

**CLIENT:**

M/S CREAM STONE

**PROJECT/LOCATION:**

CREAM STONE, WEST BULB  
@HYD AIRPORT

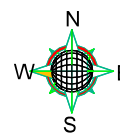

**TITLE:**

LIGHTING LOOPING LAYOUT

DRAWN: BUSHRA

DATE: 08-04-2024

SCALE :

NOT TO SCALE

**ARCHITECTS**  
SAMRAT ASSOCIATES

Architecture | interiors | Project Management


Khajaguda, Prashant Hills

Hyderabad.

040-23311009

E mail: samratarchitects@gmail.com



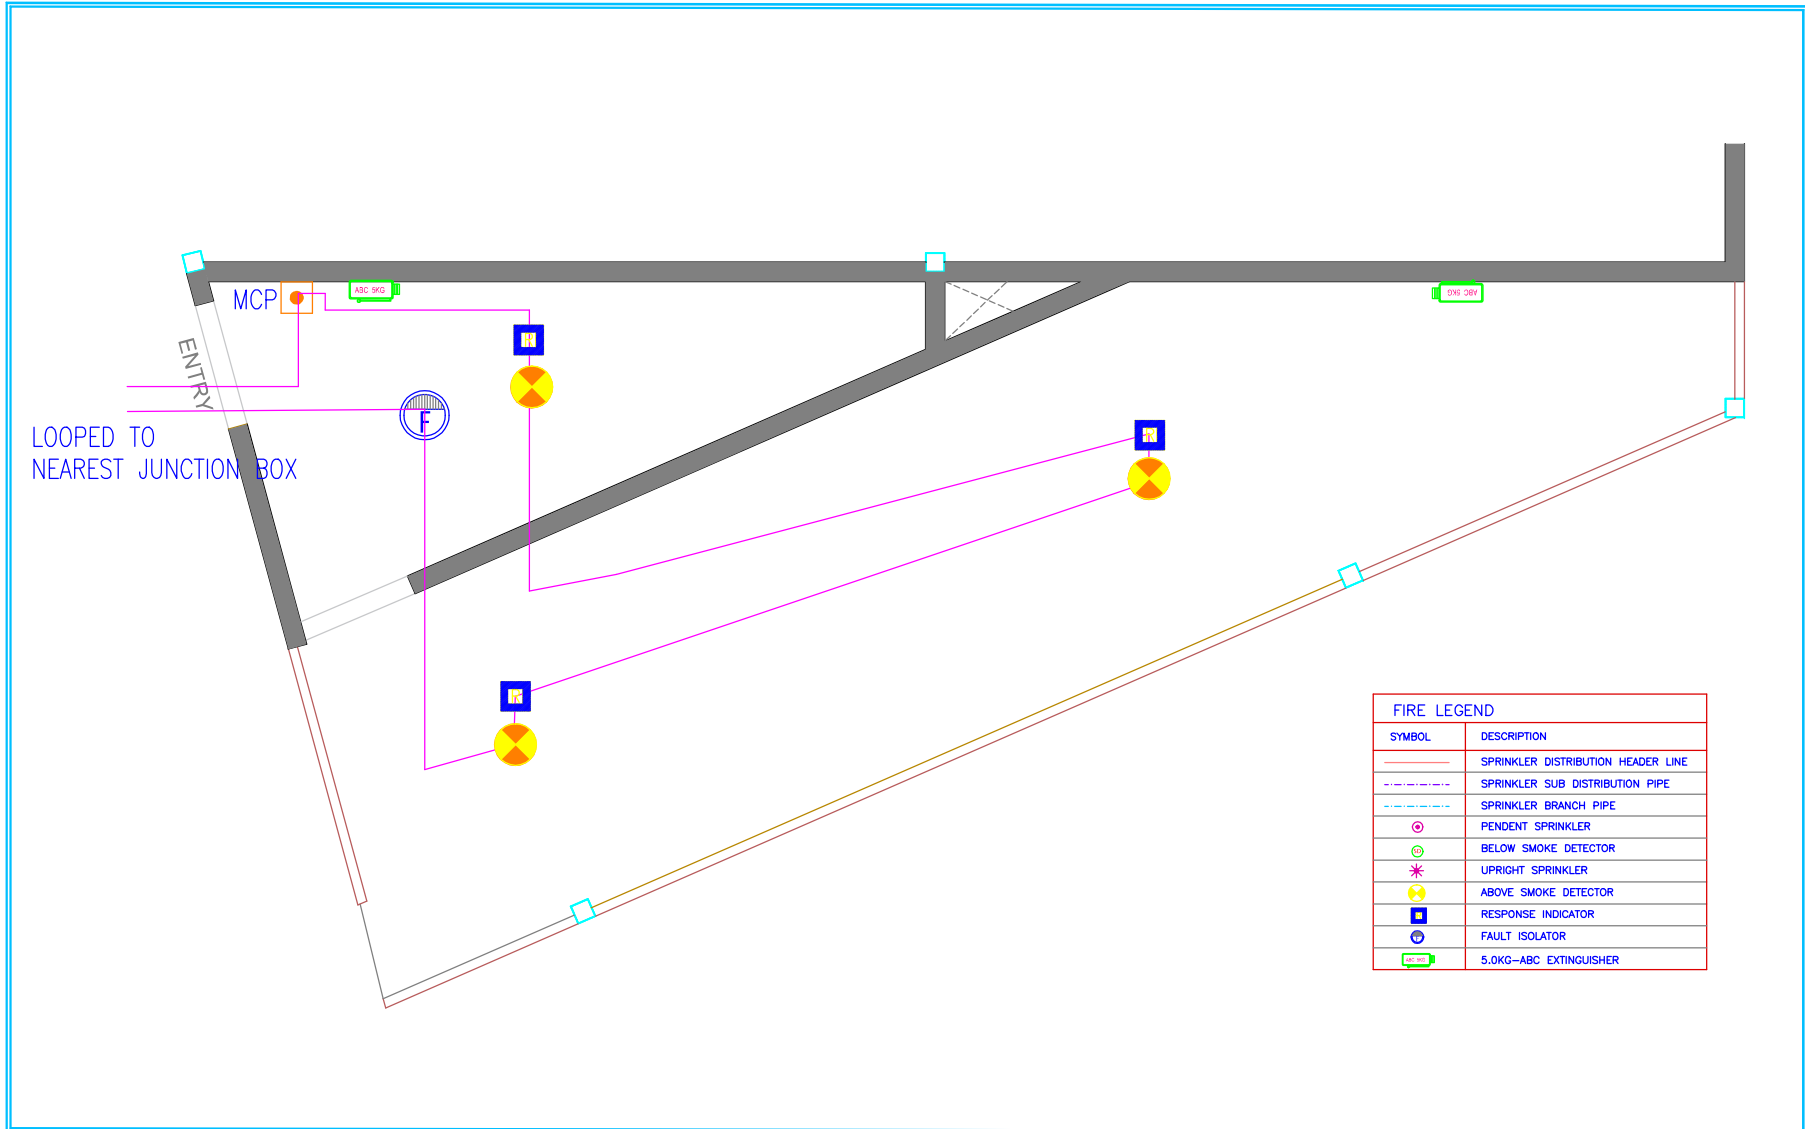

FIRE LEGEND	
SYMBOL	DESCRIPTION
	SPRINKLER DISTRIBUTION HEADER LINE
	SPRINKLER SUB DISTRIBUTION PIPE
	SPRINKLER BRANCH PIPE
	PENDENT SPRINKLER
	BELOW SMOKE DETECTOR
	UPRIGHT SPRINKLER
	ABOVE SMOKE DETECTOR
	RESPONSE INDICATOR
	FAULT ISOLATOR
	5.0KG-ABC EXTINGUISHER


**NOTE**

- All dimensions are in mm, unless specified.
- Do not scale this drawing, only written dimensions need to be followed.
- Any discrepancy in the drawing, to be brought to the notice of Architect.

The copy rights of this document is with SAMRAT ASSOCIATES, and it shouldn't be used by anybody without the written permission of Architect.

CLIENT:  
M/S CREAM STONE

PROJECT/LOCATION:  
CREAM STONE, WEST BULB  
@HYD AIRPORT

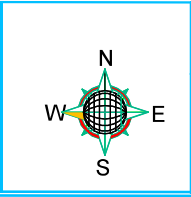

TITLE:  
FIRE ALARM LAYOUT


DRAWN: BUSHRA

DATE: 07-04-2024

SCALE:  
NOT TO SCALE

ARCHITECTS  
**SAMRAT ASSOCIATES**  
Architecture | interiors | Project Management

Khajaguda, Prashant Hills  
Hyderabad,  
040-23311009  
E.mail: samratarchitects@gmail.com

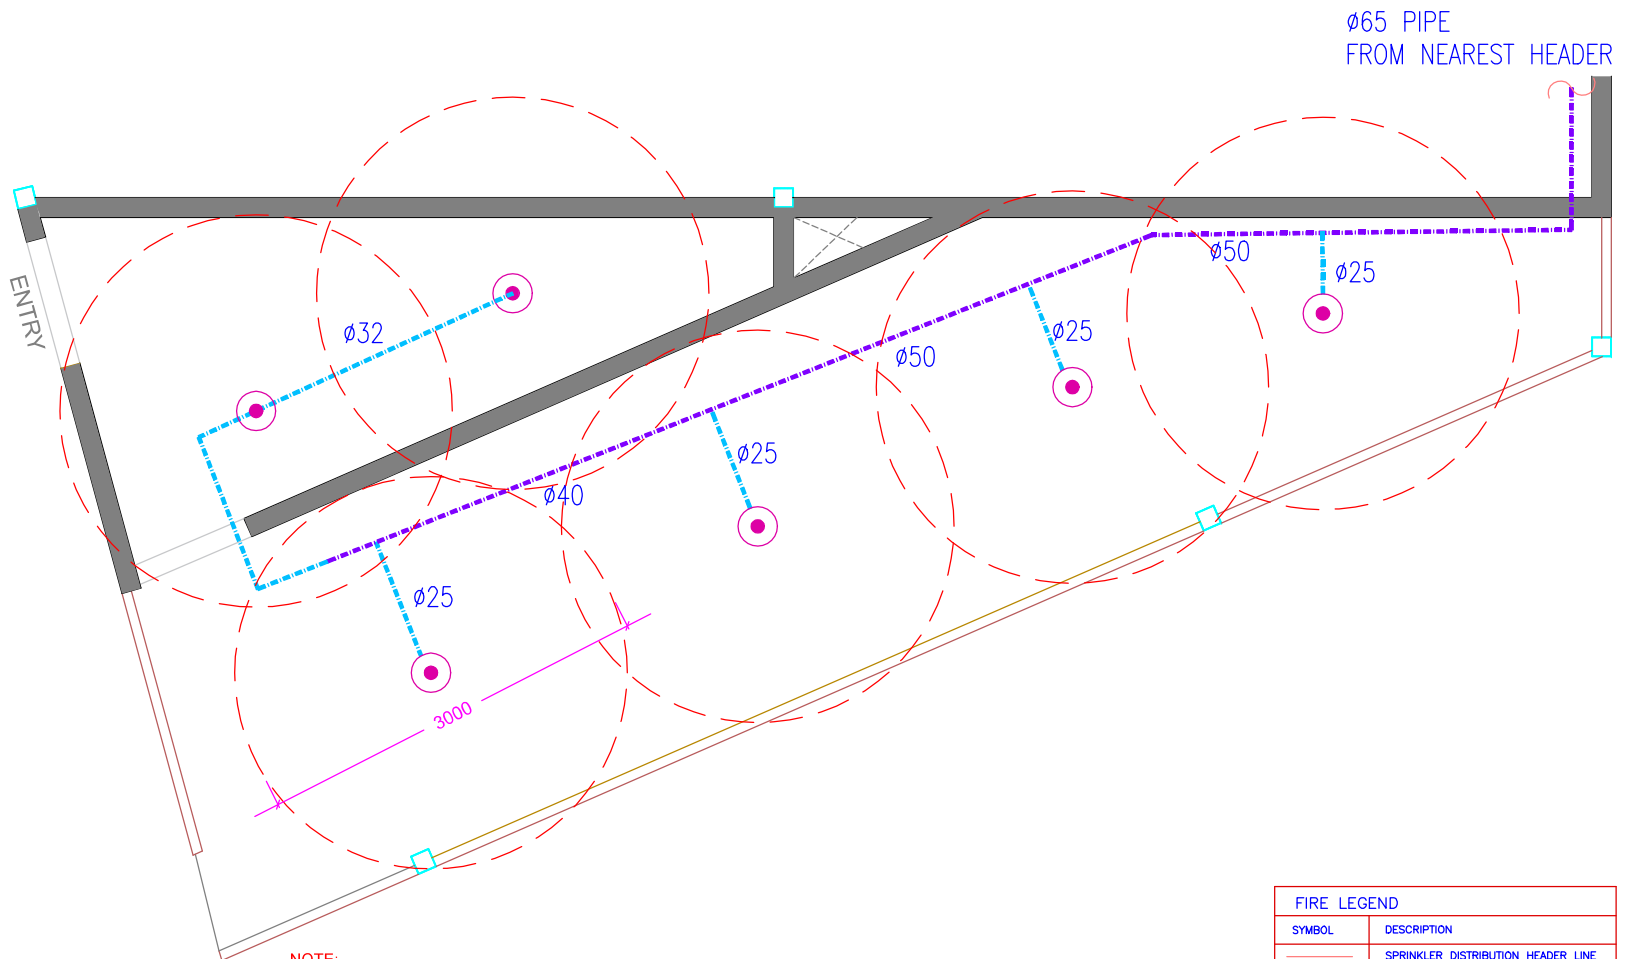

- NOTE:**
- ISOLATION VALVE (AUDCO MAKE) OF PN16 RATING SHALL BE INSTALLED AT THE TAP OFF.
  - DRAIN VALVE AND PRESSURE GAUGE SHALL BE PROVIDED AFTER BVV.
  - TRAP DOOR TO ACCESS THE VALVES.
  - SPRINKLER MARKING IS DONE AS PER MAX DIS 2700MM AND MIN DISTANCE 1500MM
  - COVORAGE AREA OF SPRINKLER IS 3000MM

FIRE LEGEND	
SYMBOL	DESCRIPTION
	SPRINKLER DISTRIBUTION HEADER LINE
	SPRINKLER SUB DISTRIBUTION PIPE
	SPRINKLER BRANCH PIPE
	PENDENT SPRINKLER
	UPRIGHT SPRINKLER

**NOTE**

- All dimensions are in mm, unless specified.
- Do not scale this drawing, only written dimensions need to be followed.
- Any discrepancy in the drawing, to be brought to the notice of Architect.


The copy rights of this document is with SAMRAT ASSOCIATES, and it shouldn't be used by anybody without the written permission of Architect.

**CLIENT:**

M/S CREAM STONE

**PROJECT/LOCATION:**

CREAM STONE, WEST BULB @HYD AIRPORT

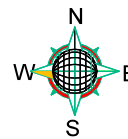

**TITLE:**

SPRINKLER LAYOUT

DRAWN: BUSHRA

DATE: 07-04-2024

SCALE :  
NOT TO SCALE

**ARCHITECTS**


**SAMRAT ASSOCIATES**

Architecture | interiors | Project Management

Khajaguda, Prashant Hills  
Hyderabad.

040-23311009

E mail: samratarchitects@gmail.com

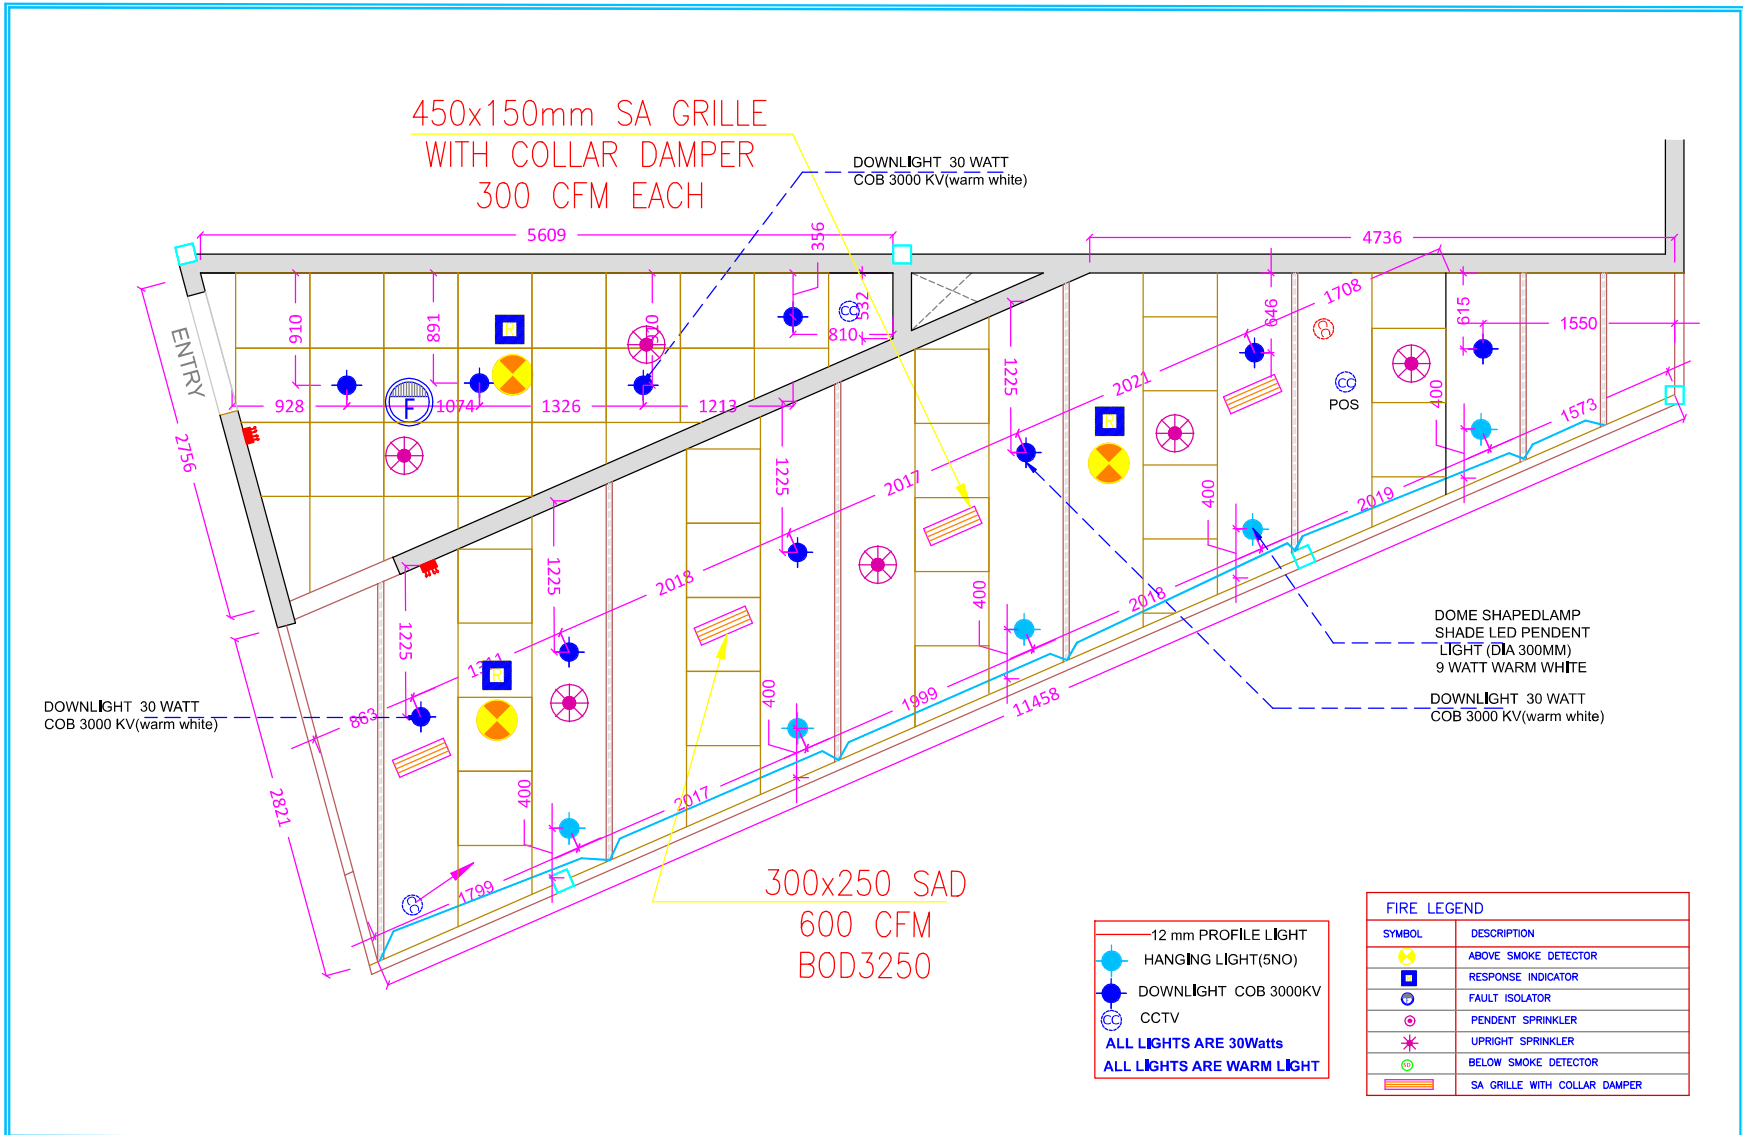

DOWNLIGHT 30 WATT  
COB 3000 KV(warm white)

DOWNLIGHT 30 WATT  
COB 3000 KV(warm white)

DOME SHAPED LAMP  
SHADE LED PENDENT  
LIGHT (DIA 300MM)  
9 WATT WARM WHITE

DOWNLIGHT 30 WATT  
COB 3000 KV(warm white)

300x250 SAD  
600 CFM  
BOD3250

- 12 mm PROFILE LIGHT
- HANGING LIGHT(5NO)
- DOWNLIGHT COB 3000KV
- Ⓢ CCTV
- ALL LIGHTS ARE 30Watts
- ALL LIGHTS ARE WARM LIGHT

FIRE LEGEND	
SYMBOL	DESCRIPTION
⊕	ABOVE SMOKE DETECTOR
Ⓢ	RESPONSE INDICATOR
⊙	FAULT ISOLATOR
⊗	PENDENT SPRINKLER
⊛	UPRIGHT SPRINKLER
⊙	BELOW SMOKE DETECTOR
▨	SA GRILLE WITH COLLAR DAMPER


**NOTE**

1. All dimensions are in mm, unless specified.
2. Do not scale this drawing, only written dimensions need to be followed.
3. Any discrepancy in the drawing, to be brought to the notice of Architect.

The copy rights of this document is with SAMRAT ASSOCIATES, and it shouldn't be used by anybody without the written permission of Architect.

CLIENT:  
M/S CREAM STONE

PROJECT/LOCATION:  
CREAM STONE, WEST BULB  
@HYD AIRPORT

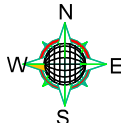


TITLE:  
RCP LAYOUT

DRAWN: BUSHRA

DATE: 08-04-2024

SCALE:  
NOT TO SCALE

ARCHITECTS  
**SAMRAT ASSOCIATES**  
Architecture | interiors | Project Management  
Khajaguda, Prashant Hills  
Hyderabad,  
040-23311009  
E mail: samratarchitects@gmail.com

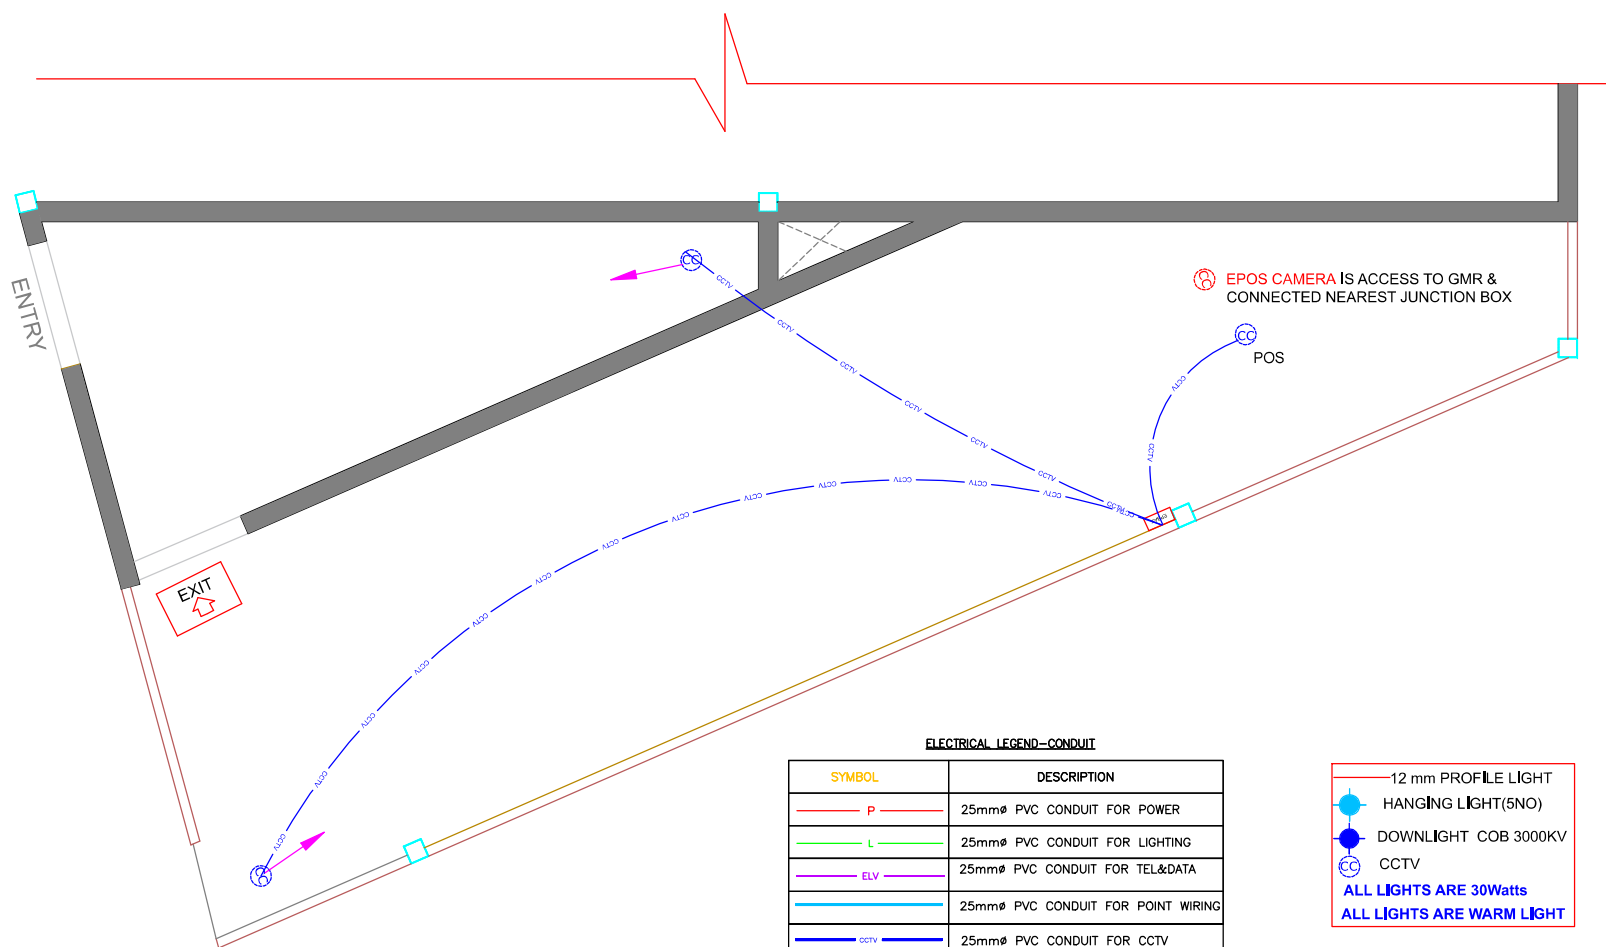

**ELECTRICAL LEGEND-CONDUIT**


SYMBOL	DESCRIPTION
	25mm $\phi$ PVC CONDUIT FOR POWER
	25mm $\phi$ PVC CONDUIT FOR LIGHTING
	25mm $\phi$ PVC CONDUIT FOR TEL&DATA
	25mm $\phi$ PVC CONDUIT FOR CCTV
	25mm $\phi$ PVC CONDUIT FOR EMERGENCY LIGHTING

12 mm PROFILE LIGHT  
 HANGING LIGHT(5NO)  
 DOWNLIGHT COB 3000KV  
 CCTV  
**ALL LIGHTS ARE 30Watts**  
**ALL LIGHTS ARE WARM LIGHT**

**NOTE:** CAT6 CABLE OF BELDEN MAKE SHALL BE MADE AVAILABLE ABOVE POS BELOW CEILING FOR FIXING GMR-EPOS CAMERA. EPOS CAMERA FIXING IN GMR SCOPE


**NOTE**  
 1. All dimensions are in mm, unless specified.  
 2. Do not scale this drawing, only written dimensions need to be followed.  
 3. Any discrepancy in the drawing, to be brought to the notice of Architect.  
 The copy rights of this document is with SAMRAT ASSOCIATES, and it shouldn't be used by anybody without the written permission of Architect.

CLIENT:  
**M/S CREAM STONE**  
 PROJECT/LOCATION:  
**CREAM STONE, WEST BULB @HYD AIRPORT**

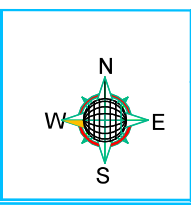

TITLE:  
**CCTV LOOPTNG**  
 DRAWN: BUSHRA  
 DATE: 07-04-2024  
 SCALE :  
**NOT TO SCALE**

ARCHITECTS  
**SAMRAT ASSOCIATES**  
 Architecture | interiors | Project Management  
 Khajaguda, Prashant Hills  
 Hyderabad,  
 040-23311009  
 E.mail: samratarchitects@gmail.com

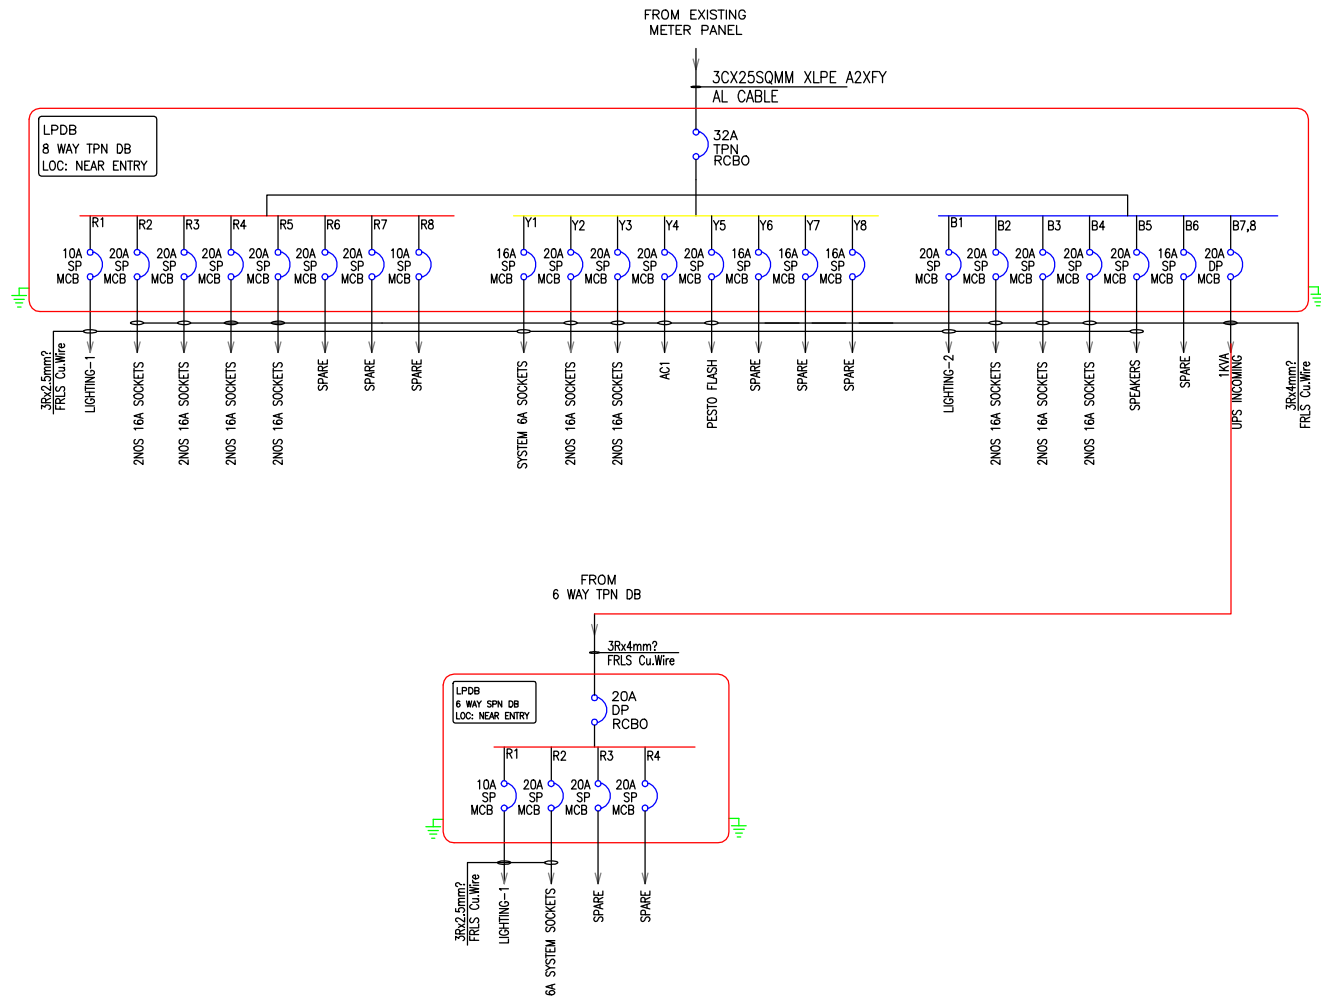


**NOTE**

- All dimensions are in mm, unless specified.
- Do not scale this drawing, only written dimensions need to be followed.
- Any discrepancy in the drawing, to be brought to the notice of Architect.

The copy rights of this document is with SAMRAT ASSOCIATES, and it shouldn't be used by anybody without the written permission of Architect.

**CLIENT:**  
M/S CREAM STONE

**PROJECT/LOCATION:**  
CREAM STONE, WEST BULB @HYD AIRPORT

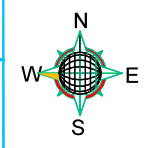

**TITLE:**  
SLD LAYOUT

**DRAWN:** BUSHRA

**DATE:** 07-04-2024

**SCALE:** NOT TO SCALE

**ARCHITECTS**  
**SAMRAT ASSOCIATES**  
Architecture | interiors | Project Management

Khajaguda, Prashant Hills  
Hyderabad.  
040-23311009

E mail: samratararchitects@gmail.com

## FF 25 CS @ AIRPORT LOAD CALCULATION

Areas	Lighting, Power
<b>POWER SOCKETS</b>	
16A SOCKETS	<b>11.00</b>
6A SOCKETS	<b>0.60</b>
LIGHTING & SIGNAGE LOAD	<b>1.50</b>
<b>Total Load in KW</b>	<b>13.10</b>
<b>Over all DF</b>	<b>0.65</b>
<b>Total Load in KW</b>	<b>8.5</b>

**NOTE**

1. All dimensions are in mm, unless specified.
2. Do not scale this drawing, only written dimensions need to be followed.
3. Any discrepancy in the drawing, to be brought to the notice of Architect.

 
The copy rights of this document is with SAMRAT ASSOCIATES, and it shouldn't be used by anybody without the written permission of Architect.

**CLIENT:**

M/S CREAM STONE

**PROJECT/LOCATION:**

CREAM STONE, WEST BULB  
@HYD AIRPORT



**TITLE:**

ELECTRICAL LOAD SHEET

DRAWN: BUSHRA

DATE: 07-03-2024

SCALE :

NOT TO SCALE

**ARCHITECTS**

**SAMRAT ASSOCIATES**

Architecture | interiors | Project Management

Khajaguda, Prashant Hills

Hyderabad.

040-23311009

E mail: samratarchitects@gmail.com

### LIGHTING LUX LEVEL CALCULATION

SNO	AREA IN Sqft	AREA Sqmt	LUX LEVEL	UF	MF	LUMEN OUTPUT	NO OF LIGHTS
STORE	97	9.01	750	0.8	0.7	3000	4.02
AS PER LIGHTING DESING 750 LUX LEVEL ARRIVED							4NO
CREAM STONE	301	27.97	700	0.8	0.7	3000	11.66
AS PER LIGHTING DESING 700 LUX LEVEL ARRIVED							11NO

**NOTE**

1. All dimensions are in mm, unless specified.
2. Do not scale this drawing, only written dimensions need to be followed.
3. Any discrepancy in the drawing, to be brought to the notice of Architect.


The copy rights of this document is with SAMRAT ASSOCIATES, and it shouldn't be used by anybody without the written permission of Architect.

CLIENT:

M/S CREAM STONE

PROJECT/LOCATION:

CREAM STONE, WEST BULB @HYD AIRPORT

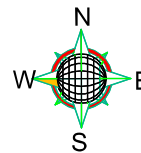

TITLE:

LUX LEVEL CALCULATION SHEET

DRAWN: BUSHRA

DATE: 07-03-2024

SCALE :

NOT TO SCALE

ARCHITECTS

**SAMRAT ASSOCIATES**

Architecture | Interiors | Project Management

Khajaguda, Prashant Hills

Hyderabad.

040-23311009

E mail: samratarchitects@gmail.com