



LIST OF DRAWINGS		
#	DESCRIPTION	DWG.No
1	COVER SHEET	02GA-001
2	GENERAL NOTES & FINISHES SCHEDULE	02GA-002
3	FURNITURE, LIGHT & FIXTURE LEGEND	02GA-003
4	DETAIL DRAWING LEGEND	02GA-004
PLANS		
5	GENERAL ARRANGEMENT PLAN	02GA-100
6	EQUIPMENT LAYOUT PLAN	02GA-101
7	SETTING OUT PLAN	02GA-102
8	RCP+ LIGHTING LAYOUT	02GA-103
9	FLOORING LAYOUT	02GA-104
10	WATER PROOFING LAYOUT	02GA-105
11	FINISHES PLAN	02GA-106
ELEVATIONS & SECTIONS		
12	ELEVATION-01	03IL-300
13	ELEVATION-02	03IL-301

14	ELEVATION-03 & J04-SWING DOOR DETAIL	03IL-302
15	SECTION-01	03IL-303
DETAIL DRAWINGS		
16	J01 & J02-FRONT COUNTER & LEDGE DETAIL-PART:A	04DE-400
17	J01 & J02-FRONT COUNTER & LEDGE DETAIL-PART:B	04DE-401
18	J01 & J02-FRONT COUNTER & LEDGE DETAIL-PART:C	04DE-402
19	J01 & J02-FRONT COUNTER & LEDGE DETAIL-PART:D	04DE-403
20	J03-BULKHEAD DETAIL-PART:A	04DE-404
21	J03-BULKHEAD DETAIL-PART:B	04DE-405
22	J03-BULKHEAD DETAIL-PART:C	04DE-406
23	J03-BULKHEAD DETAIL-PART:D	04DE-407
24	J03-BULKHEAD DETAIL-PART:E	04DE-408
25	J03-BULKHEAD DETAIL-PART:F	04DE-409
26	J03-BULKHEAD DETAIL-PART:G	04DE-410
27	J03-BULKHEAD DETAIL-PART:H	04DE-411
28	J03-BULKHEAD DETAIL-PART:I	04DE-412
29	J05-SIGNAGE & LOGO DETAIL	04DE-413

TO1	02.02.24	TENDER	HOD	NM
REV	DATE	DESCRIPTION	DRN	CHK



PROJECT
HATTI KAAPI FF52
GMR INTERNATIONAL
AIRPORT LIMITED,
HYDERABAD

DRAWING TITLE
COVER SHEET

SCALE: NTS DATE: 02.02.2024 DRAWN: HOD A3 SHEET

STATUS
TENDER

ORG	PROJECT NO	DRAWING TYPE	NUMBER	REV
TFS	XXXX	02GA	001	T01

GENERAL NOTES

ALL DIMENSIONS ARE IN MM UNLESS OTHERWISE MENTIONED.
DO NOT SCALE THE DRAWING.
FOLLOW WRITTEN DIMENSIONS ONLY. IN CASE OF ANY DISCREPANCY IN DIMENSIONS/DETAILS AT SITE, PLEASE REFER IT BACK TO THE ARCHITECT.

THE MAIN CONTRACTOR IS EXPECTED TO COORDINATE THE DESIGNS/SITE EXECUTION WITH THE DESIGNS/DETAILS/WORKS OF THE SUB-CONTRACTOR/ VENDOR (E.G. PLUMBING CONTRACTOR). IN CASE OF ANY DISCREPANCY IN DIMENSIONS/DETAILS AT SITE, PLEASE REFER IT BACK TO THE ARCHITECT.


THE DRAWINGS/ DETAILS PROVIDED ARE MEANT TO CLARIFY DESIGN INTENT/DESIGN APPEARANCE ONLY. THE CONTRACTOR IS EXPECTED TO DEVELOP HIS/HER OWN DETAILS TO ENSURE STRUCTURAL STABILITY/ FUNCTIONING OF THE DETAIL IN LINE WITH THE DESIGN INTENT GIVEN.

THE DRAWINGS/DETAILS PROVIDED DO NOT CONTAIN ANY IRONMONGERY (E.G. HINGES, SCREWS, ANGLES ETC.) SPECIFICATIONS OR DETAILS. IT IS EXPECTED THE CONTRACTOR WILL SUITABLY DETAIL THE BUILD-UPS WITH THE RIGHT FITTINGS/IRONMONGERY TO ENSURE STRUCTURAL STABILITY/ FUNCTIONING OF THE DETAIL IN LINE WITH THE DESIGN INTENT GIVEN.

ALL SHOP DRAWINGS, MAKE/MATERIAL, FIXTURES TO BE PRESENTED TO ARCHITECT FOR REVIEW AND VALIDATION.

ALL TAP-OFF POINTS (E.G. FOR POWER, WATER, DRAINAGE ETC.) TO BE VALIDATED AT SITE PRIOR TO COMMENCEMENT OF WORK.

SYMBOLS & ABBREVIATIONS

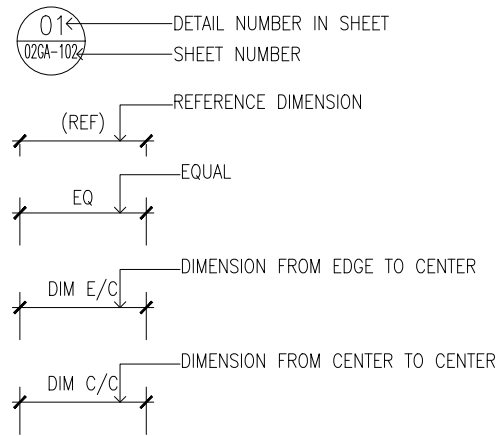

FINISHES SCHEDULE								
#	FINISH CODE	SURFACE	FINISH TYPE	DESCRIPTION/DETAIL	FINISH	REFERENCE/BRAND	WEBUNK	IMAGE
WOOD								
1	WD01	BULKHEAD	WOOD	20X10MM OAK WOOD SLATS WITH MELAMINE POLISH	MATTE	LOCALLY SOURCED	NA	
2	WD02	FRONT COUNTER	WOOD	20X20MM OAK WOOD SLATS WITH CLEAR PU FINISH	MATTE	LOCALLY SOURCED	NA	
PAINT								
3	PT01	METAL FRAMES(BULKHEAD)	ENAMEL	BLACK GREY COLOUR PAINT RAL:9005	MATTE	ASIAN PAINTS / EQUIVALENT	https://www.asianpaints.com/products/paints-and-textures.html	
4	PT02	FRONT COUNTER	EMULSION	GREY COLOUR PAINT GREY HARE-N COLOUR CODE:K295	MATTE	ASIAN PAINTS / EQUIVALENT	https://www.asianpaints.com/catalogue/colour-catalogue/gray-wall-colours/gray-hare-n.html	
5	PT03	FRONT COUNTER	EMULSION	WHITE COLOUR PAINT ABSOLUTE WHITE COLOUR CODE:L161	MATTE	ASIAN PAINTS / EQUIVALENT	https://www.asianpaints.com/catalogue/colour-catalogue/off-white-wall-colours/absolute-white.html	
LAMINATE								
6	LMD1	LEDGE,FRONT COUNTER , BOX & SWING DOOR	LAMINATE	PARIA OAK WOOD LAMINATE	MATTE	CENTURY-PARIA OAK CODE:394	https://www.centuryply.com/centurylaminate/single.php?productid=169&productname=paria-oak&catsoak&sku=3474	
7	LMD2	INSIDE FASCIA&REAR FASCIA(FRONT COUNTER)	LAMINATE	GREY COLOUR LAMINATE	MATTE	CENTURY-GREY CODE:80232	https://www.centuryply.com/centurylaminate/single.php?productid=562	
METAL								
8	MT01	METAL SKIRTING	METAL	BLACK GREY COLOUR POWDER COAT RAL:9005	MATTE	LOCALLY SOURCED	NA	
9	MT02	FRONT COUNTER (FASCIA)	METAL	BRASS FINISH METAL TRIM	MIRROR FINISH	LOCALLY SOURCED	NA	
COUNTER TOP								
10	SJ01	COUNTER TOP & BOX	CORIAN	WHITE COLOUR MARBLE CORIAN	MATTE	CORIAN-ENDURA ANCIENT MARBLE	https://www.endura.corian.com/	
POLYCARBONATE								
11	PC01	BULKHEAD	POLYCARBONATE	8MM THK TRANSPARENT FLUTED POLYCARBONATE SHEET	MATTE	LOCALLY SOURCED	NA	
FLOORING								
12	FL01	FLOOR (SERVERY&FOH)	CERAMIC TILE	600x600MM GREY COLOUR KOTA STONE	MATTE	SIMPOLO-SOLID DOVE: SOLID ASH/EQUIVALENT	https://www.simpolo.net/product-detail/minimo/minimo-collection/solid-dove_solid-ash	
13	FL02	FLOOR TRIM	STAINLESS STEEL	S.S.304 GRADE T-SHAPE TRANSITION TRIM	MATTE	SDS-PROFILES / EQUIVALENT	https://sdspfiles.com/product/s304-t-shape-t-profilenow-available-in-pure-sds-brand/	
GRAPHICS								
14	GR01	GLASS	VINYL	FROSTED FINISH VINYL STICKER	NEUTRAL	LOCALLY SOURCED	NA	
GLASS								
15	GL01	BOX	NEUTRAL	8MM THK TOUGHENED GLASS	NEUTRAL	LOCALLY SOURCED	NA	
CONTRACTOR TO SUBMIT SAMPLES FOR APPROVAL								

ALL DIMENSIONS MUST BE CHECKED ON SITE.
INFORM THE ENGINEER OF ANY DISCREPANCIES PRIOR TO CONSTRUCTION.

T01 02.02.24 TENDER HOD NM
REV DATE DESCRIPTION DRN CHK




PROJECT
HATTI KAAPI FF52
GMR INTERNATIONAL
AIRPORT LIMITED,
HYDERABAD


DRAWING TITLE
GENERAL NOTES & FINISHES
FINISHES SHEDULE

SCALE NTS DATE 02.02.2024 DRAWN HOD A3 SHEET

STATUS
TENDER

ORG PROJECT NO DRAWING TYPE NUMBER REV
TFS XXXX 02GA 002 T01


FURNITURE LEGEND					
SL.NO	CODE	DESCRIPTION	QTY	REFERENCE/BRAND	IMAGE
1	HC	HIGH CHAIR WOODEN BACK REST,SEAT FRAME MATERIAL: METAL SEAT: CHARCOAL COLOUR FAUX LEATHER UPHOLSTERY CHAIR HEIGHT:1016MM CHAIR WIDTH:508MM CHAIR LENGTH:444.5MM SEAT HEIGHT:762MM SUPPLIER:ALLMODERN	4	https://www.allmodern.com/furniture/pdp/bud-a-counter-bar-stool-a100014671.html?piid=146420805%2C146420804%2C146420801	

LIGHT & FIXTURE LEGEND					
SI.NO	CODE	DESCRIPTION	Qty	REFERENCE/BRAND	IMAGE
1	LT01	TRACK LIGHT BLACK BODY ESSENTIAL SMARTBRIGHT PROJECTOR GEN 2-ST033T LIGHT TEMP:3000K	8	https://www.lighting.philips.co.in/prof/indoor-luminaires/projectors/essential-smartbright-projector-gen-2/911401889882_EU/product	
2	LT02	LED STRIP LIGHT WITH DIFFUSER LIGHT TEMP:3000K	6.82M	https://havells.com/en/consumer/lighting/led%20strips/flexion-strip-light/flexion-led-strip-24-w-rgb.html	
3	DD	32" DIGITAL DISPLAY LG LED TV MODELNO-32TNF5J /EQUIVALENT	3	https://www.lg-informationdisplay.com/product/digital-signage/interactive/32TNF5J	



PROJECT
 HATTI KAAPI FF52
 GMR INTERNATIONAL
 AIRPORT LIMITED,
 HYDERABAD

DRAWING TITLE
 FURNITURE, LIGHT &
 FIXTURE LEGEND

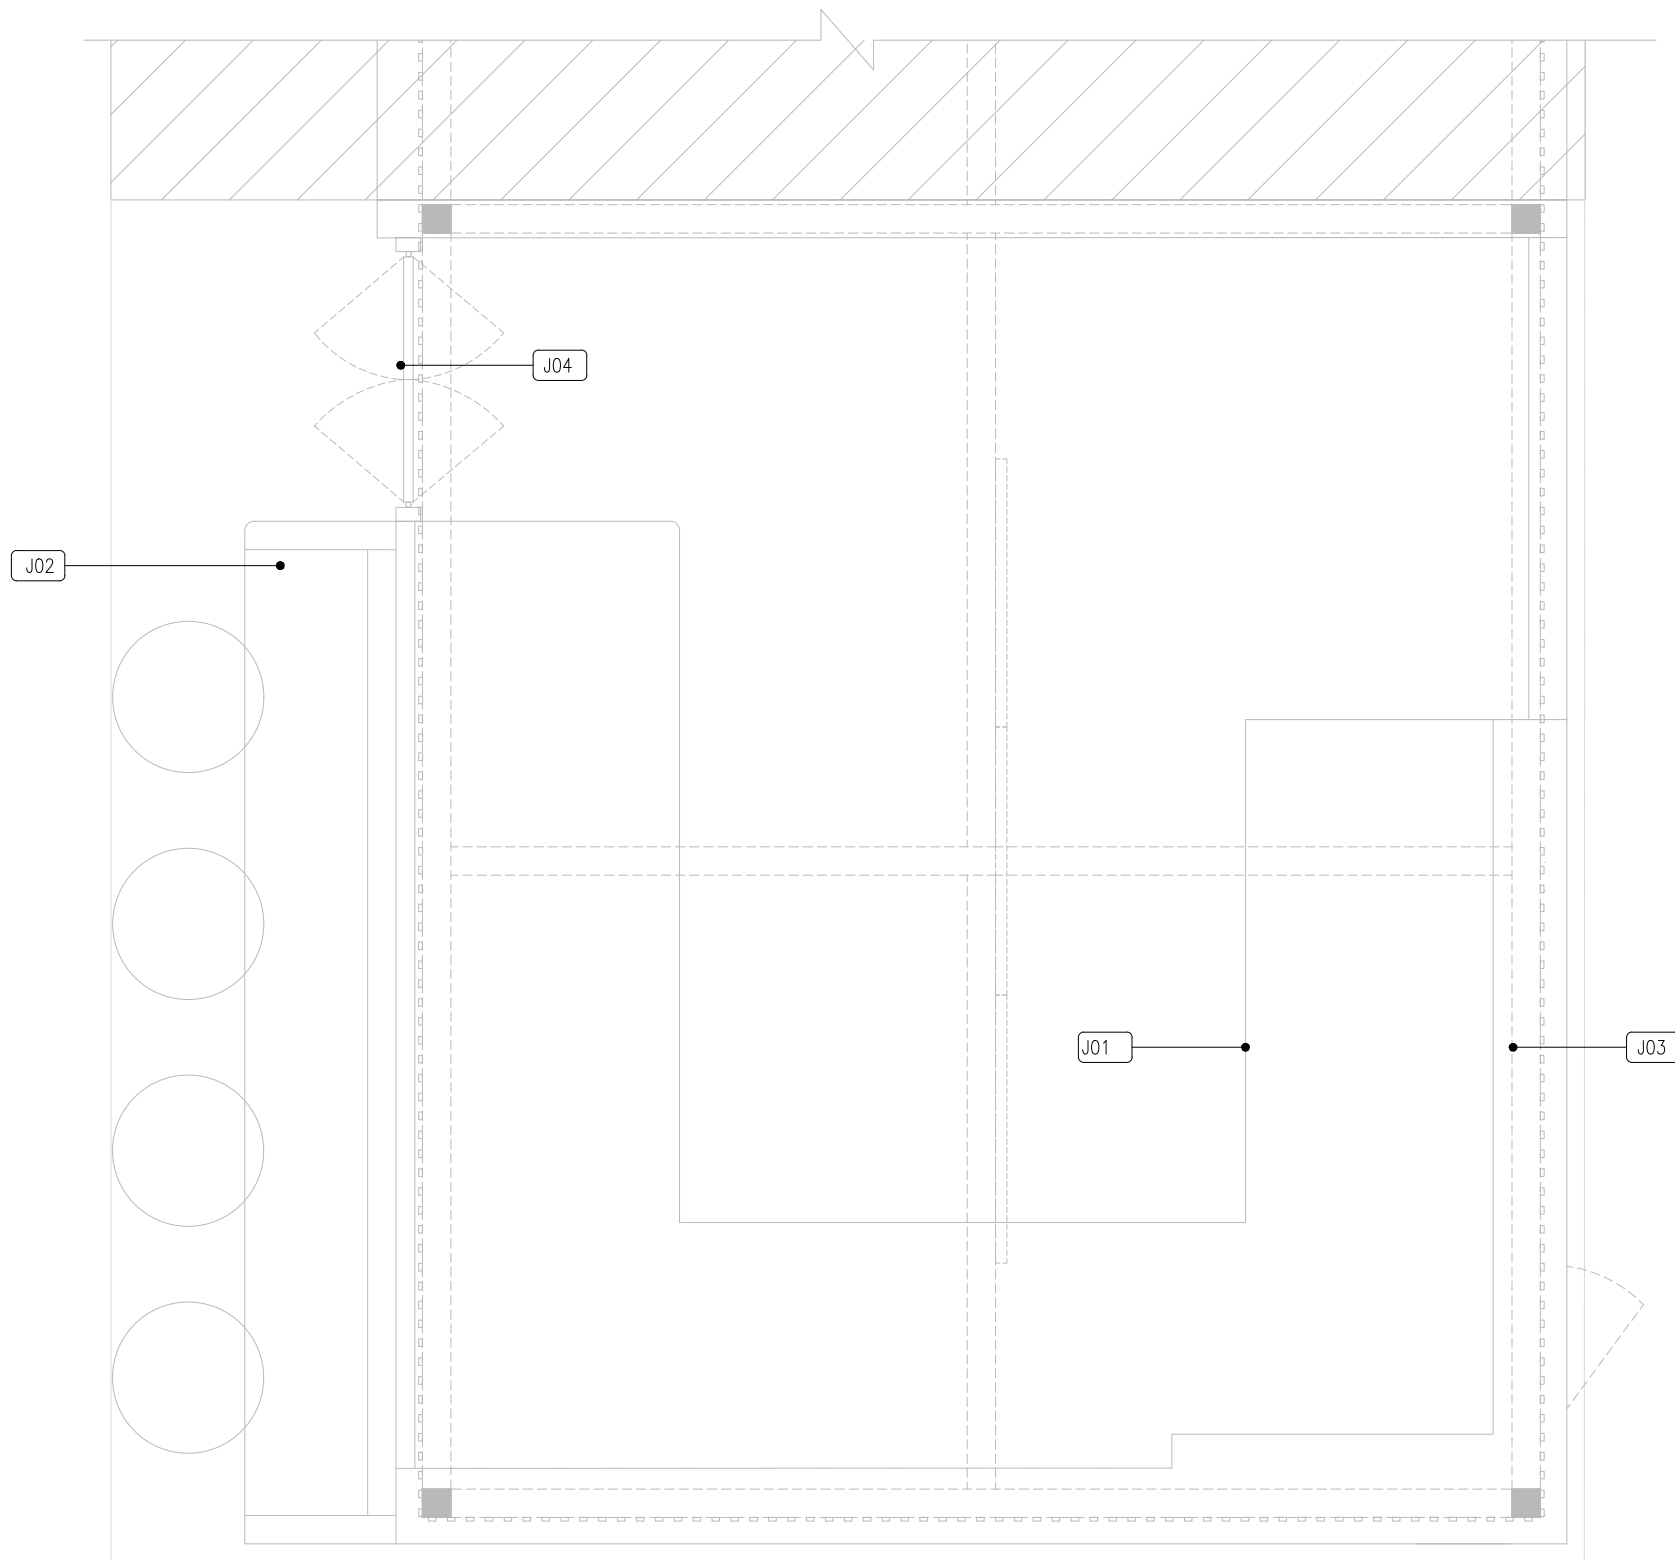

DETAIL DRAWING LEGEND		
CODE	DESCRIPTION	ADDITIONAL INFORMATION
J01	FRONT COUNTER DETAIL	REFER: 04DE-400 TO 04DE-403
J02	LEDGE DETAIL	REFER: 04DE-400 TO 04DE-403
J03	BULKHEAD DETAIL	REFER: 04DE-404 TO 04DE-412
J04	SWING DOOR DETAIL	REFER: 03IL-302
J05	SIGNAGE & LOGO DETAIL	REFER: 04DE-413

01 DETAIL DRAWING LEGEND

02GA-004 1:20

REV	DATE	DESCRIPTION	HOD	NM
			DRN	CHK



PROJECT
HATTI KAAPI FF52
GMR INTERNATIONAL
AIRPORT LIMITED,
HYDERABAD


DRAWING TITLE
DETAIL DRAWING LEGEND

SCALE 1:20 DATE 02.02.2024 DRAWN HOD A3 SHEET

STATUS
TENDER

ORG	PROJECT NO	DRAWING TYPE	NUMBER	REV
TFS	XXXX	02GA	004	T01

- INDICATES HATTI KAAPI DEMISE
- INDICATES CHAI POINT DEMISE
- INDICATES PROPOSED SIGNAGE
- INDICATES PROPOSED LOGO SIGNAGE

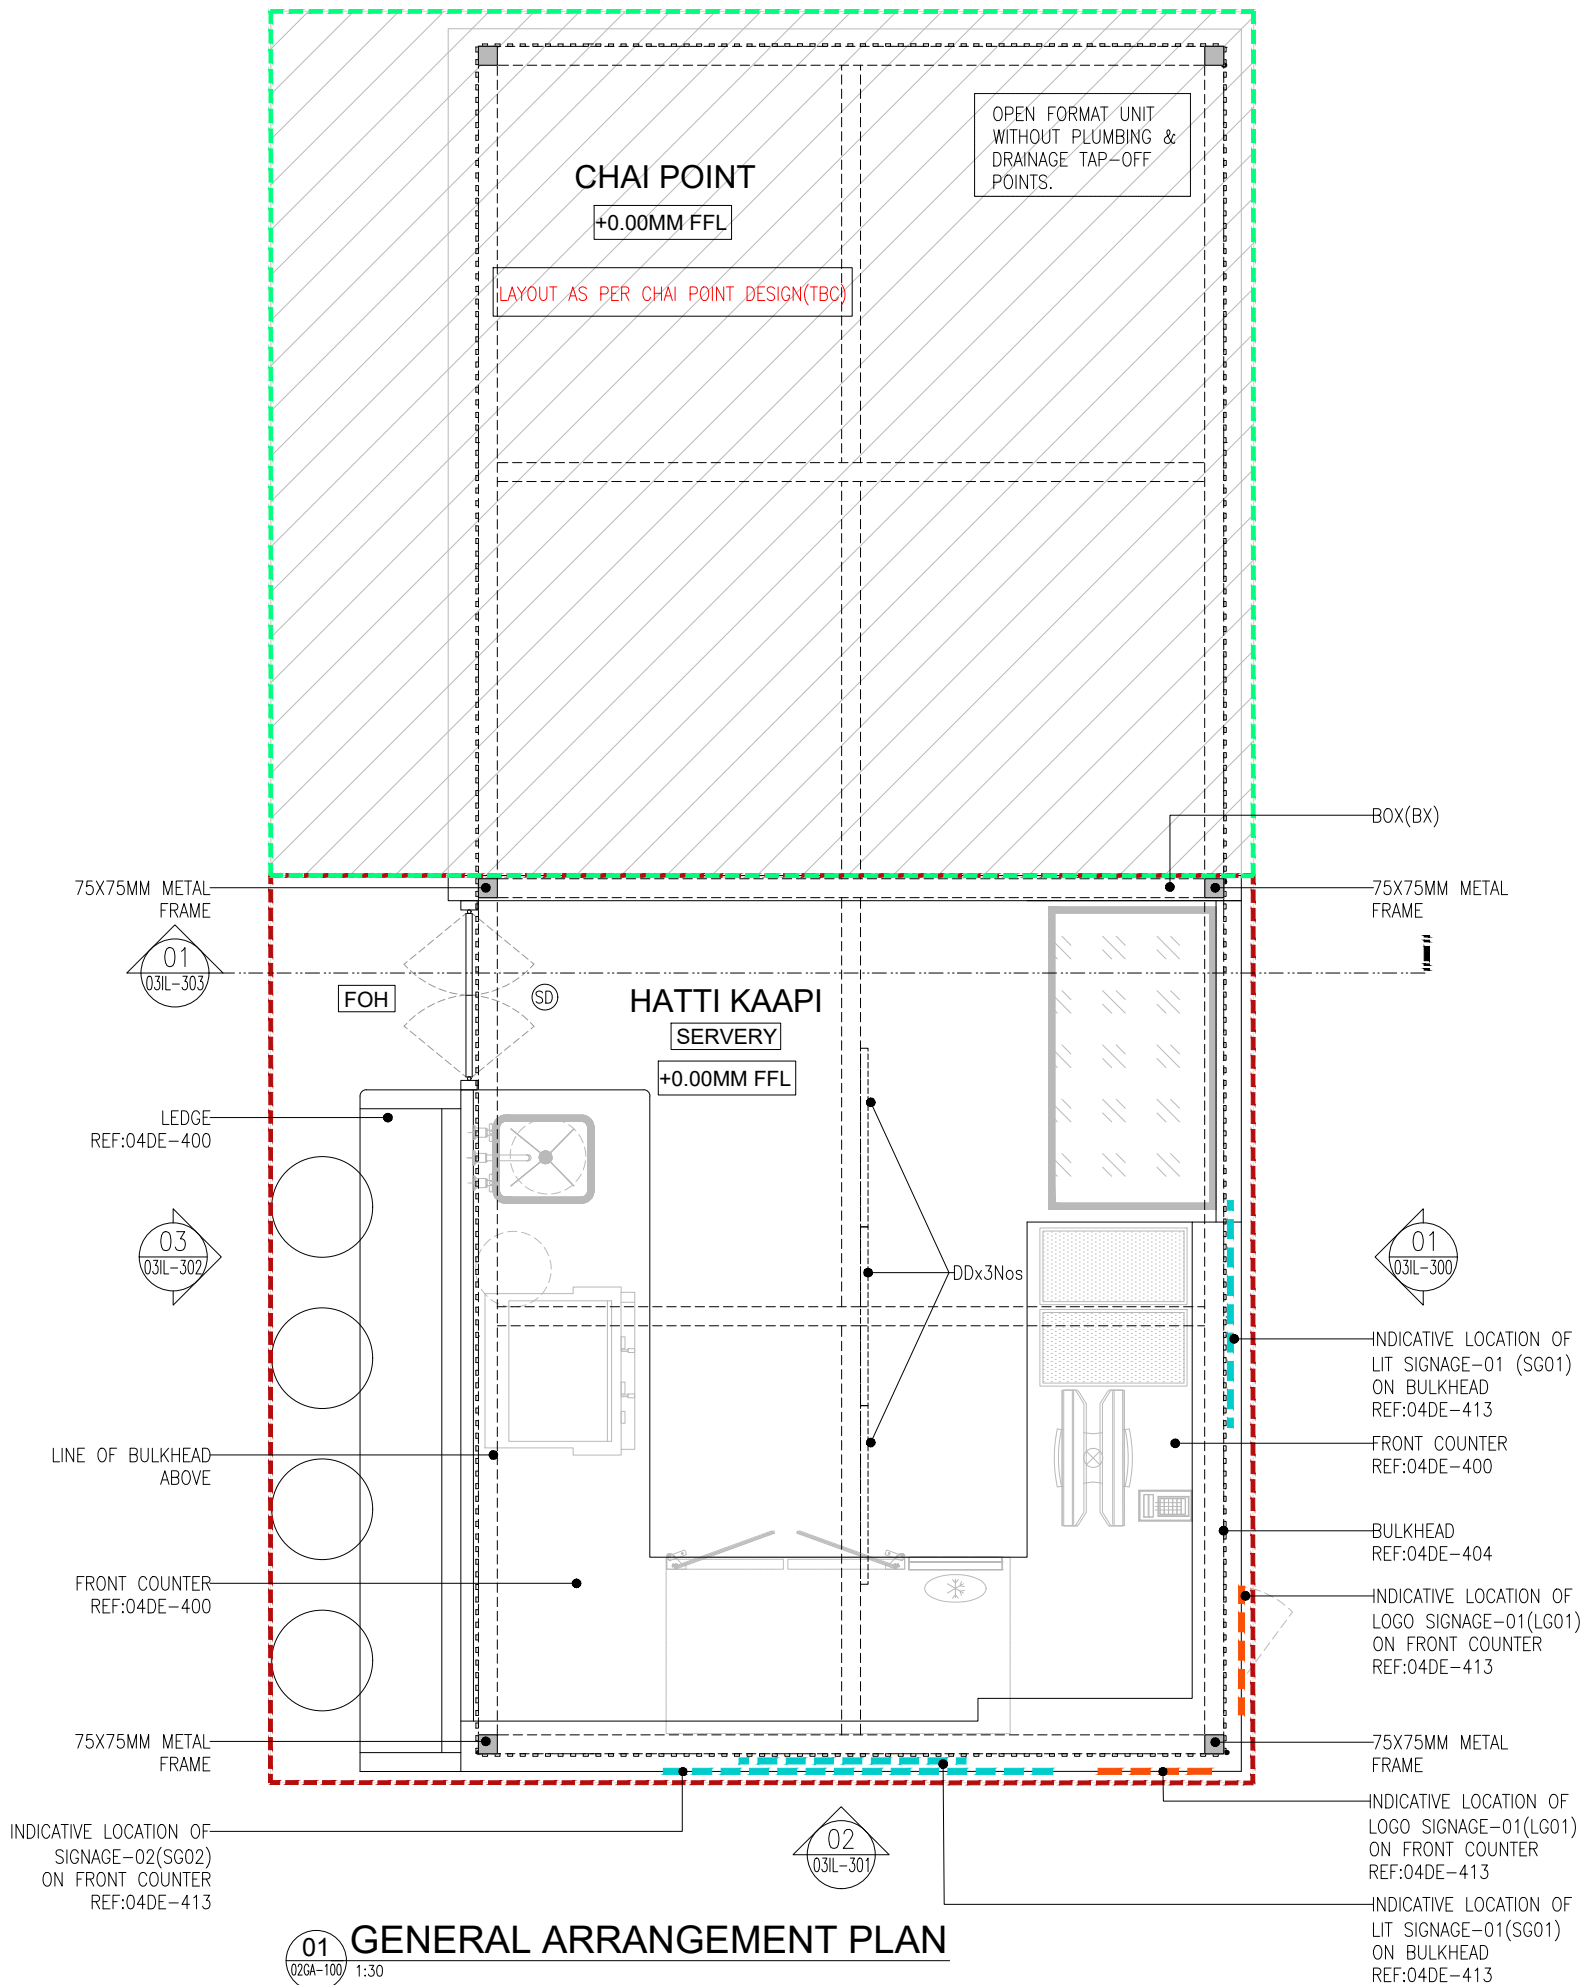

DOOR LEGEND							
SL.NO	CODE	DESCRIPTION	SWING	SIZE (LxH)	VISION PANEL	FIRE RATED	COUNT
01	SD	SWING DOOR	DOUBLE	750X770MM	NO	1 HR	01

BOX LEGEND					
SL.NO	CODE	DESCRIPTION	SIZE (LxW)	HEIGHT	COUNT
01	BX	PLY BOX	3095X100MM	1000MM	01

DIGITAL DISPLAY LEGEND			
SL.NO	CODE	DESCRIPTION	COUNT
01	DD	32" DIGITAL DISPLAY	03

AREA STATEMENT		
SL.NO	DESCRIPTION	AREA(M ²)
01	FOH	3.01
02	SERVERY	11.0
TOTAL		14.01

COVERS LEGEND		
SL.NO	DESCRIPTION	COUNT
01	HIGH SEATING	04
TOTAL		04

TO1 02.02.24 TENDER HOD NM
REV DATE DESCRIPTION DRN CHK



PROJECT
HATTI KAAPI FF52
GMR INTERNATIONAL
AIRPORT LIMITED,
HYDERABAD


DRAWING TITLE
GENERAL ARRANGEMENT PLAN

SCALE 1:30 DATE 02.02.2024 DRAWN HOD A3 SHEET

STATUS
TENDER

ORG PROJECT NO DRAWING TYPE NUMBER REV
TFS XXXX 02GA 100 T01

01 GENERAL ARRANGEMENT PLAN
02GA-100 1:30

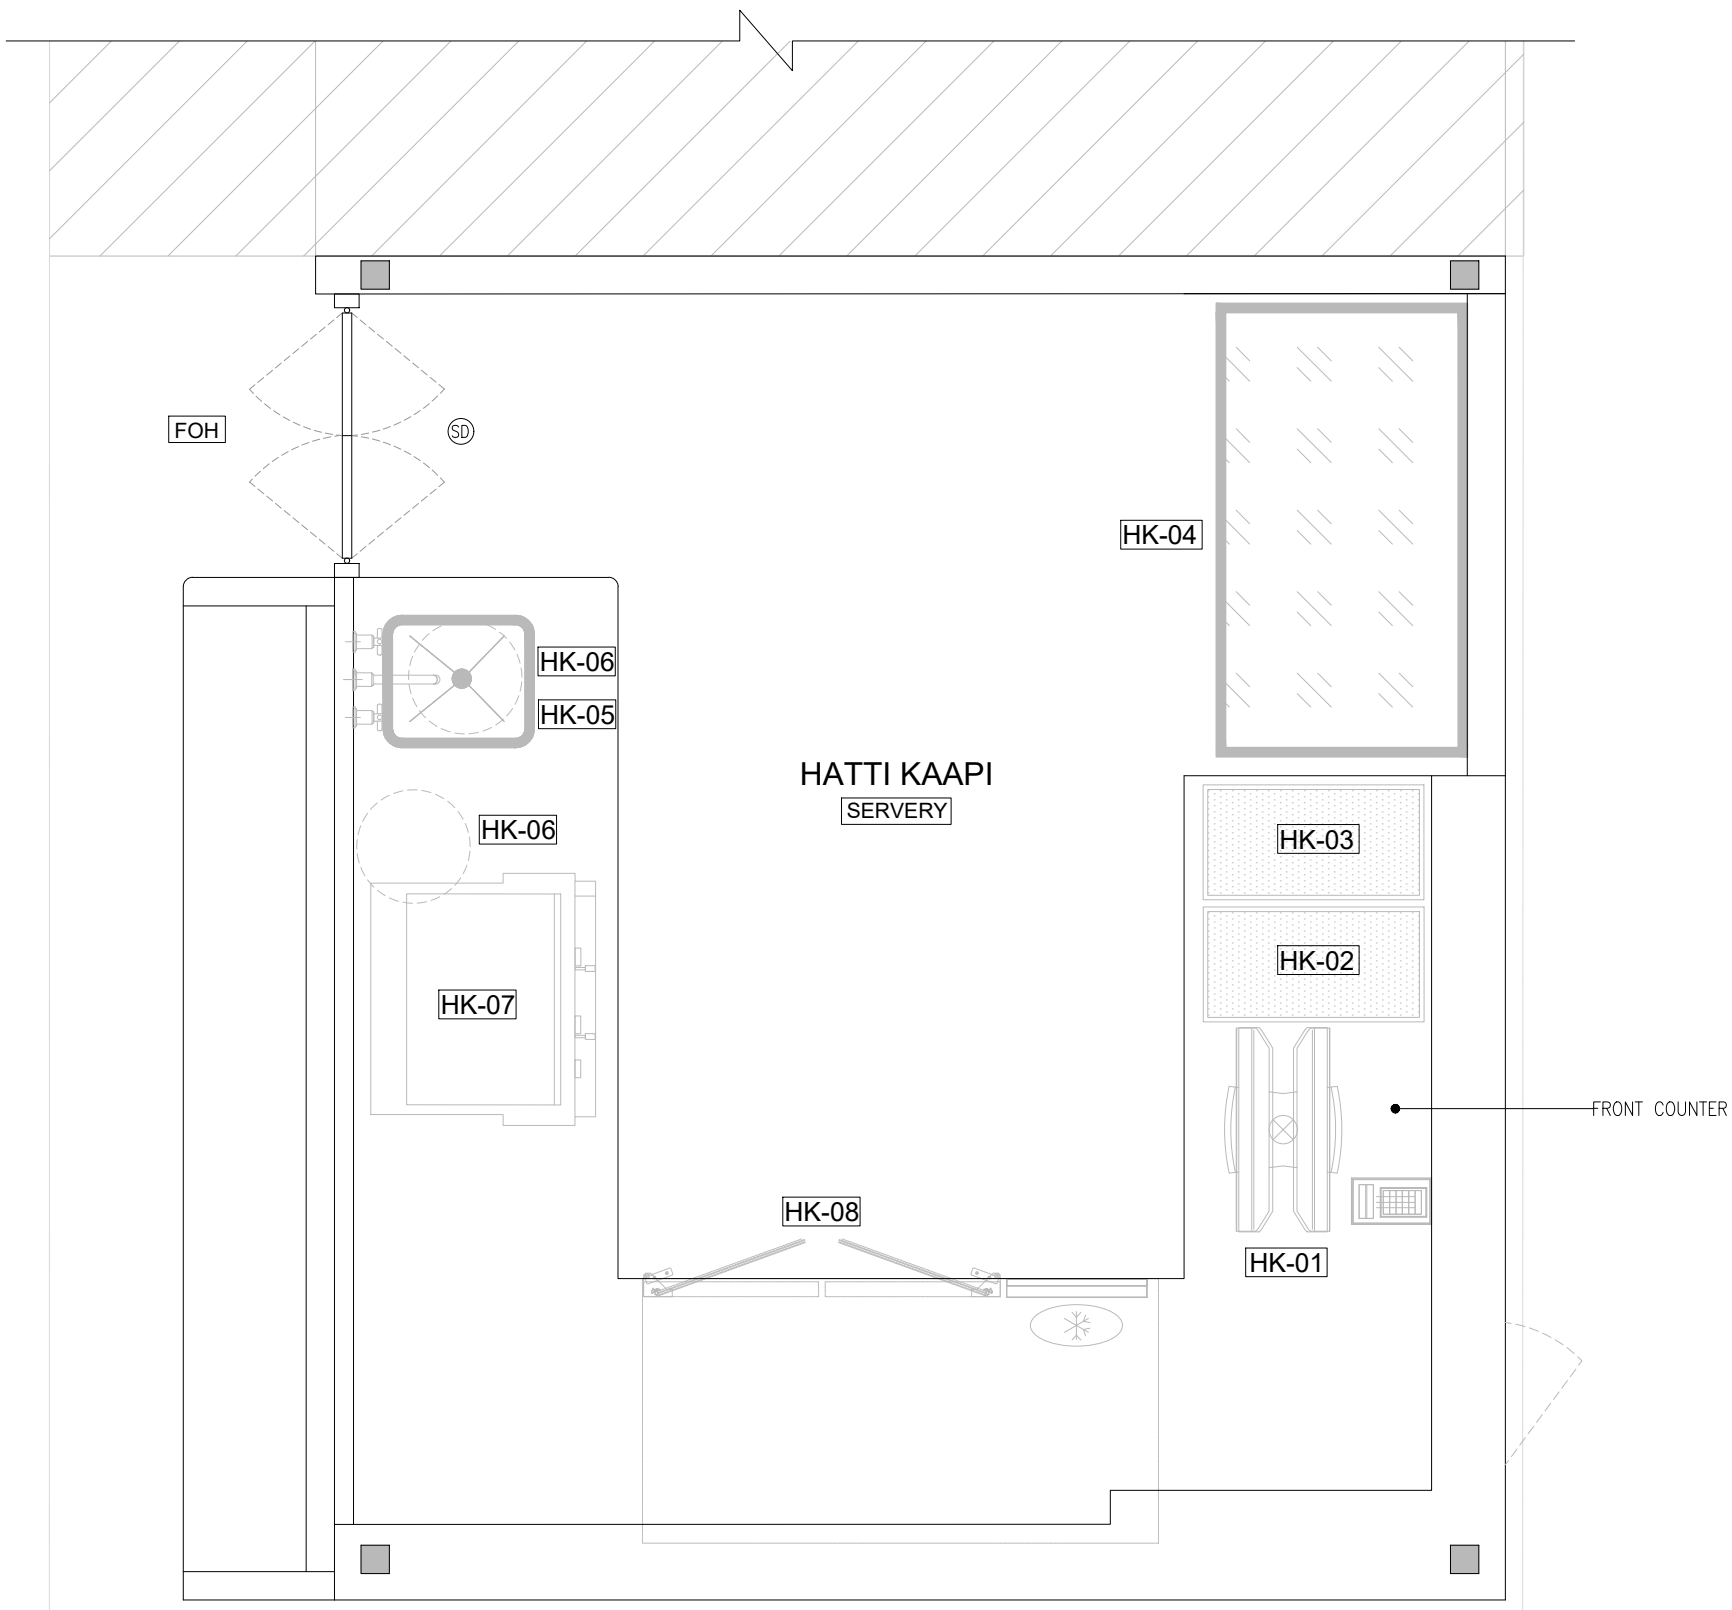

EQUIPMENT LEGEND		
ITEM	DESCRIPTION	QTY
HK-01	DUAL POS	1
HK-02	SLIM BIN DRY GARBAGE	1
HK-03	SLIM BIN WET GARBAGE	1
HK-04	DISPLAY CABINET	1
HK-05	SINK	1
HK-06	U/C JAR FOR DRAIN & WATER INLET	1
HK-07	COFFEE / TEA VENDING MACHINE	1
HK-08	2 DOOR U/C REFRIGERATOR	1

TO1	02.02.24	TENDER	HOD NM
REV	DATE	DESCRIPTION	DRN CHK



PROJECT
HATTI KAAPi FF52
GMR INTERNATIONAL
AIRPORT LIMITED,
HYDERABAD


DRAWING TITLE
EQUIPMENT LAYOUT

SCALE 1:20 DATE 02.02.2024 DRAWN HOD A3 SHEET

STATUS
TENDER

ORG	PROJECT NO	DRAWING TYPE	NUMBER	REV
TFS	XXXX 02GA	101	T01	

01 EQUIPMENT LAYOUT
02GA-101 1:20

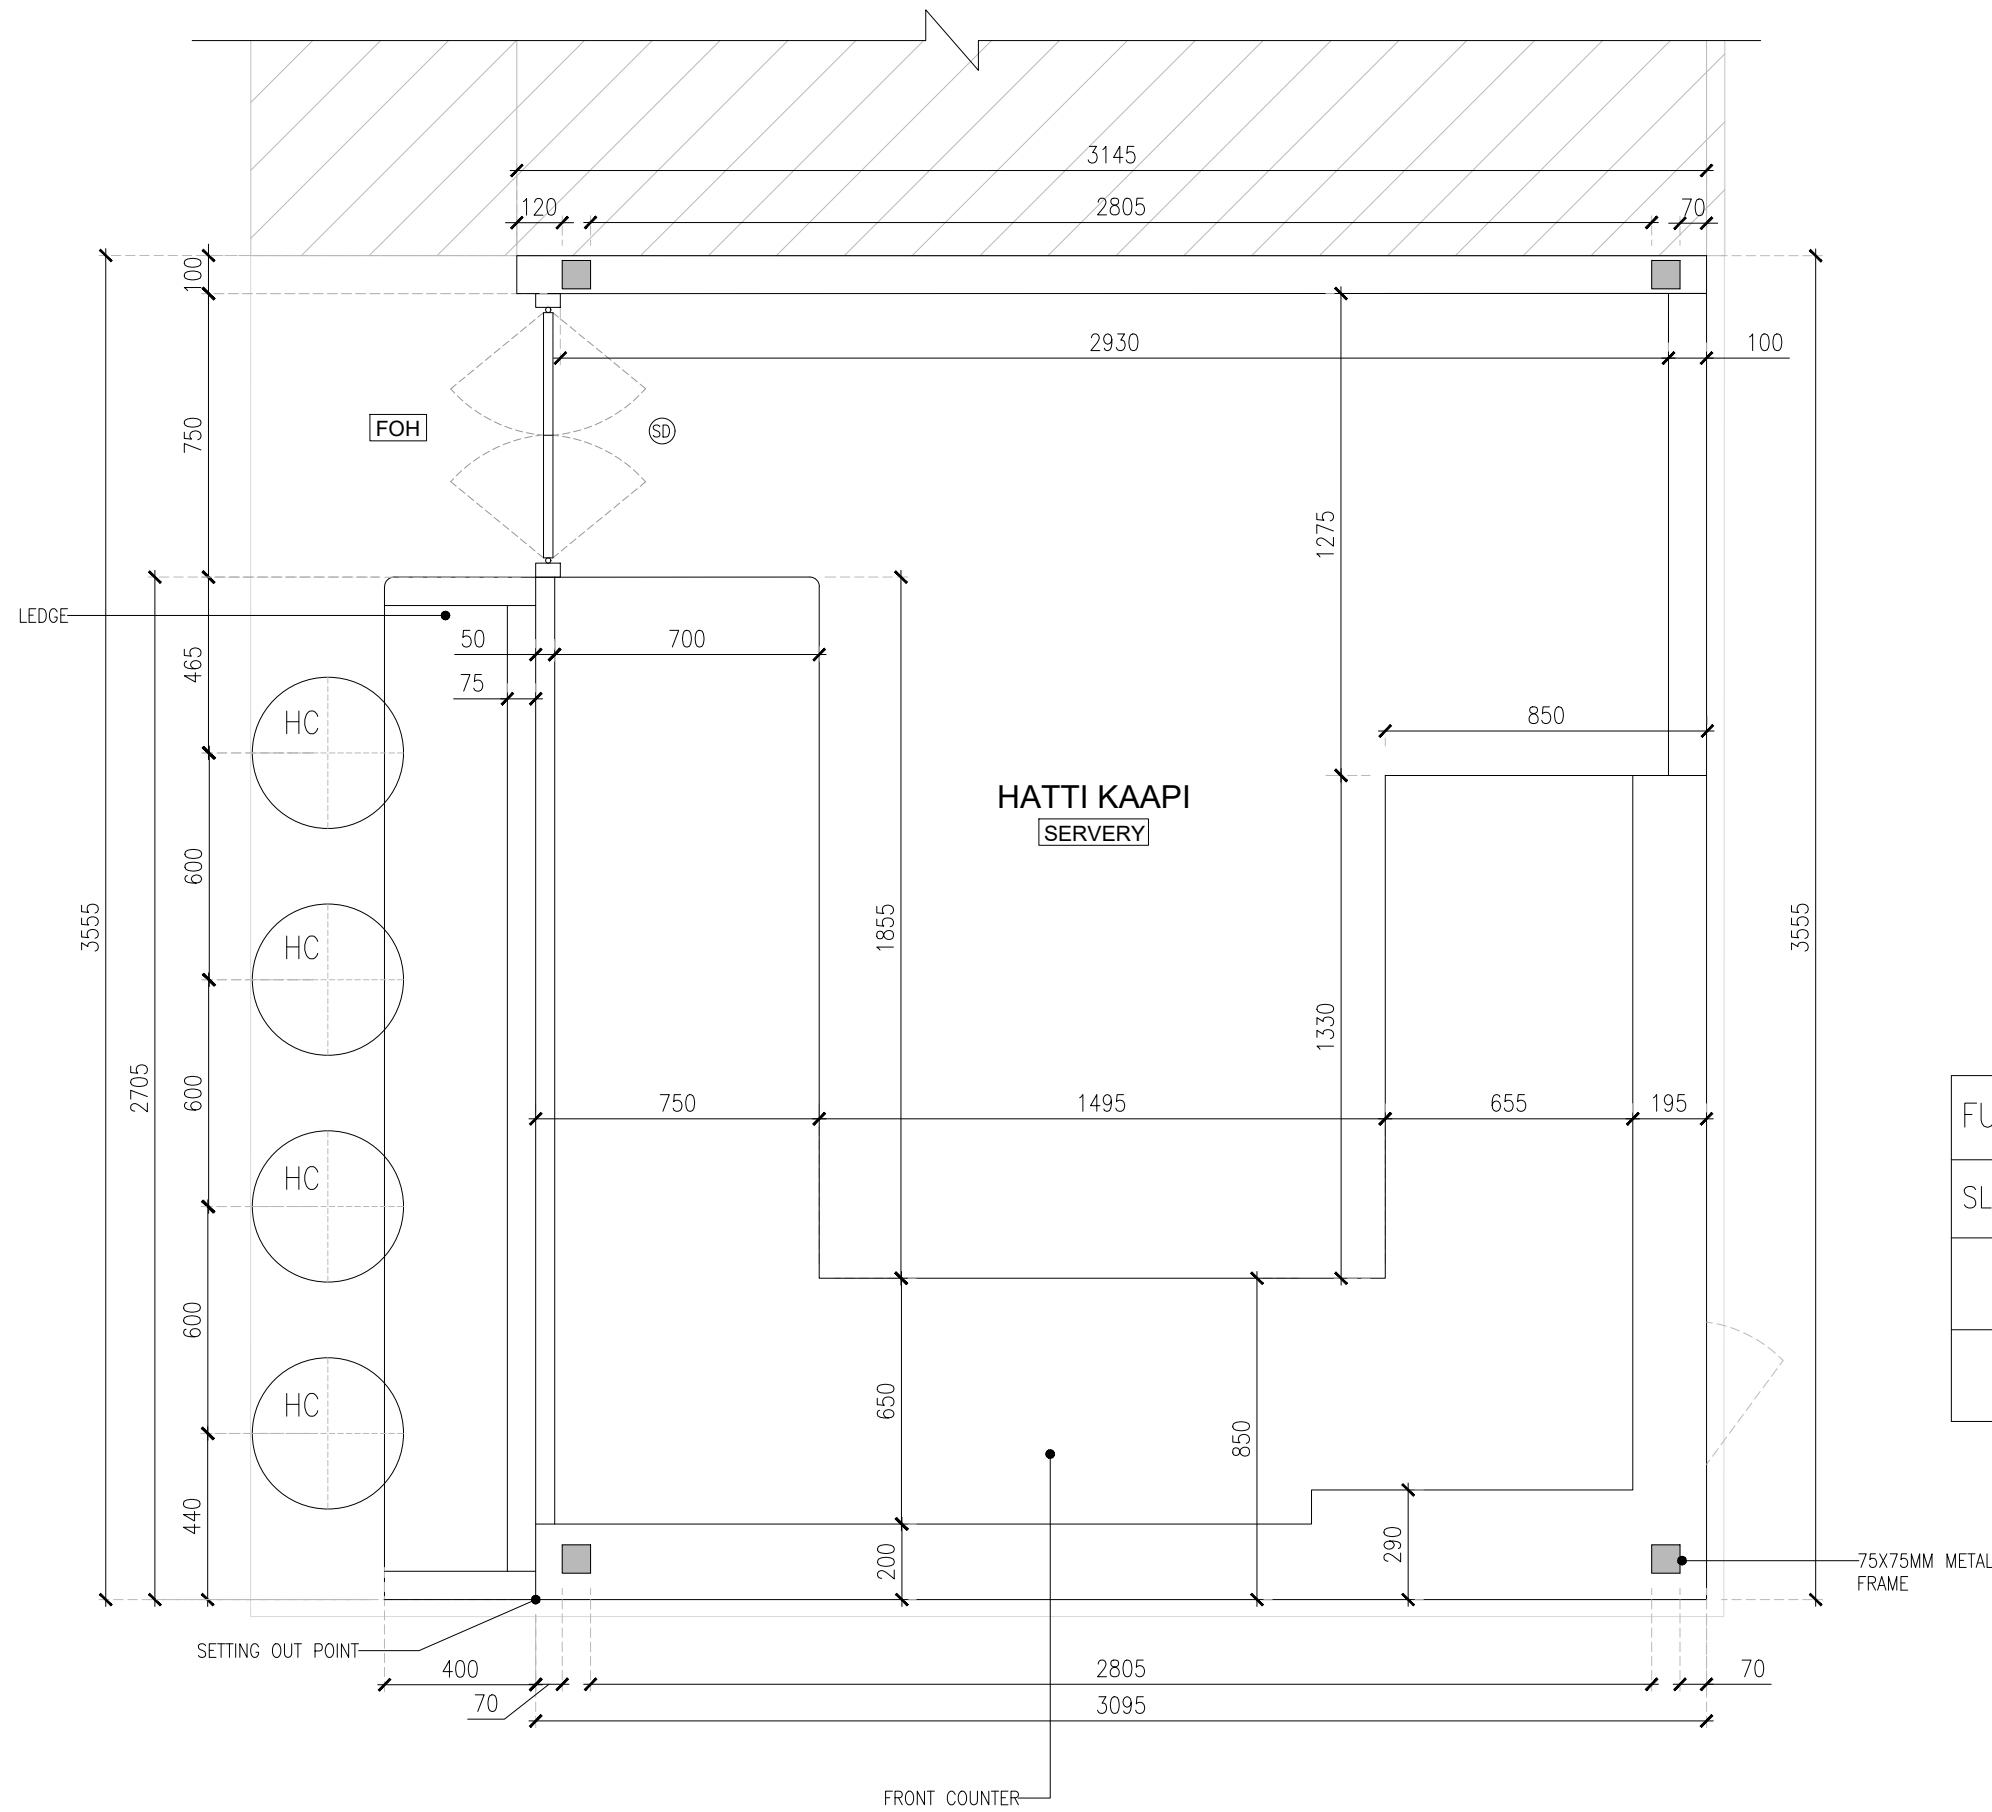

FURNITURE LEGEND			
SL.NO	CODE	DESCRIPTION	COUNT
01	HC	HIGH CHAIR	04
TOTAL			04

TO1 02.02.24 TENDER HOD NM
REV DATE DESCRIPTION DRN CHK



PROJECT
HATTI KAAPI FF52
GMR INTERNATIONAL
AIRPORT LIMITED,
HYDERABAD



DRAWING TITLE
SETTING OUT PLAN

SCALE 1:20 DATE 02.02.2024 DRAWN HOD A3 SHEET

STATUS
TENDER

ORG PROJECT NO DRAWING TYPE NUMBER REV
TFS XXXX 02GA 102 T01

01 SETTING OUT PLAN
02GA-102 1:20

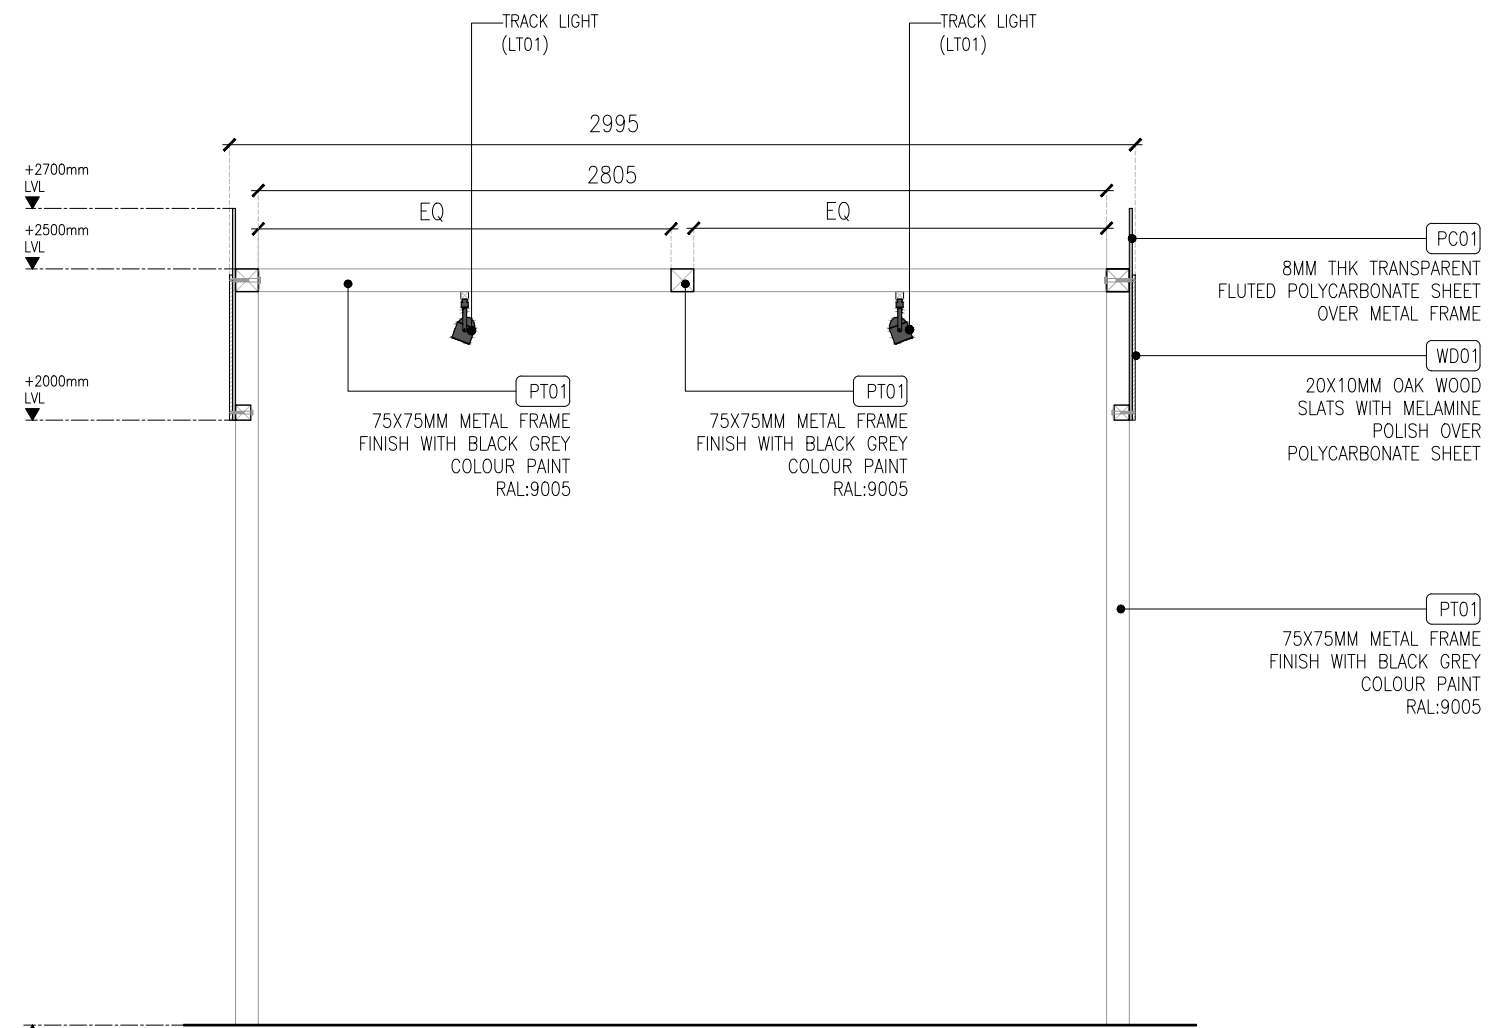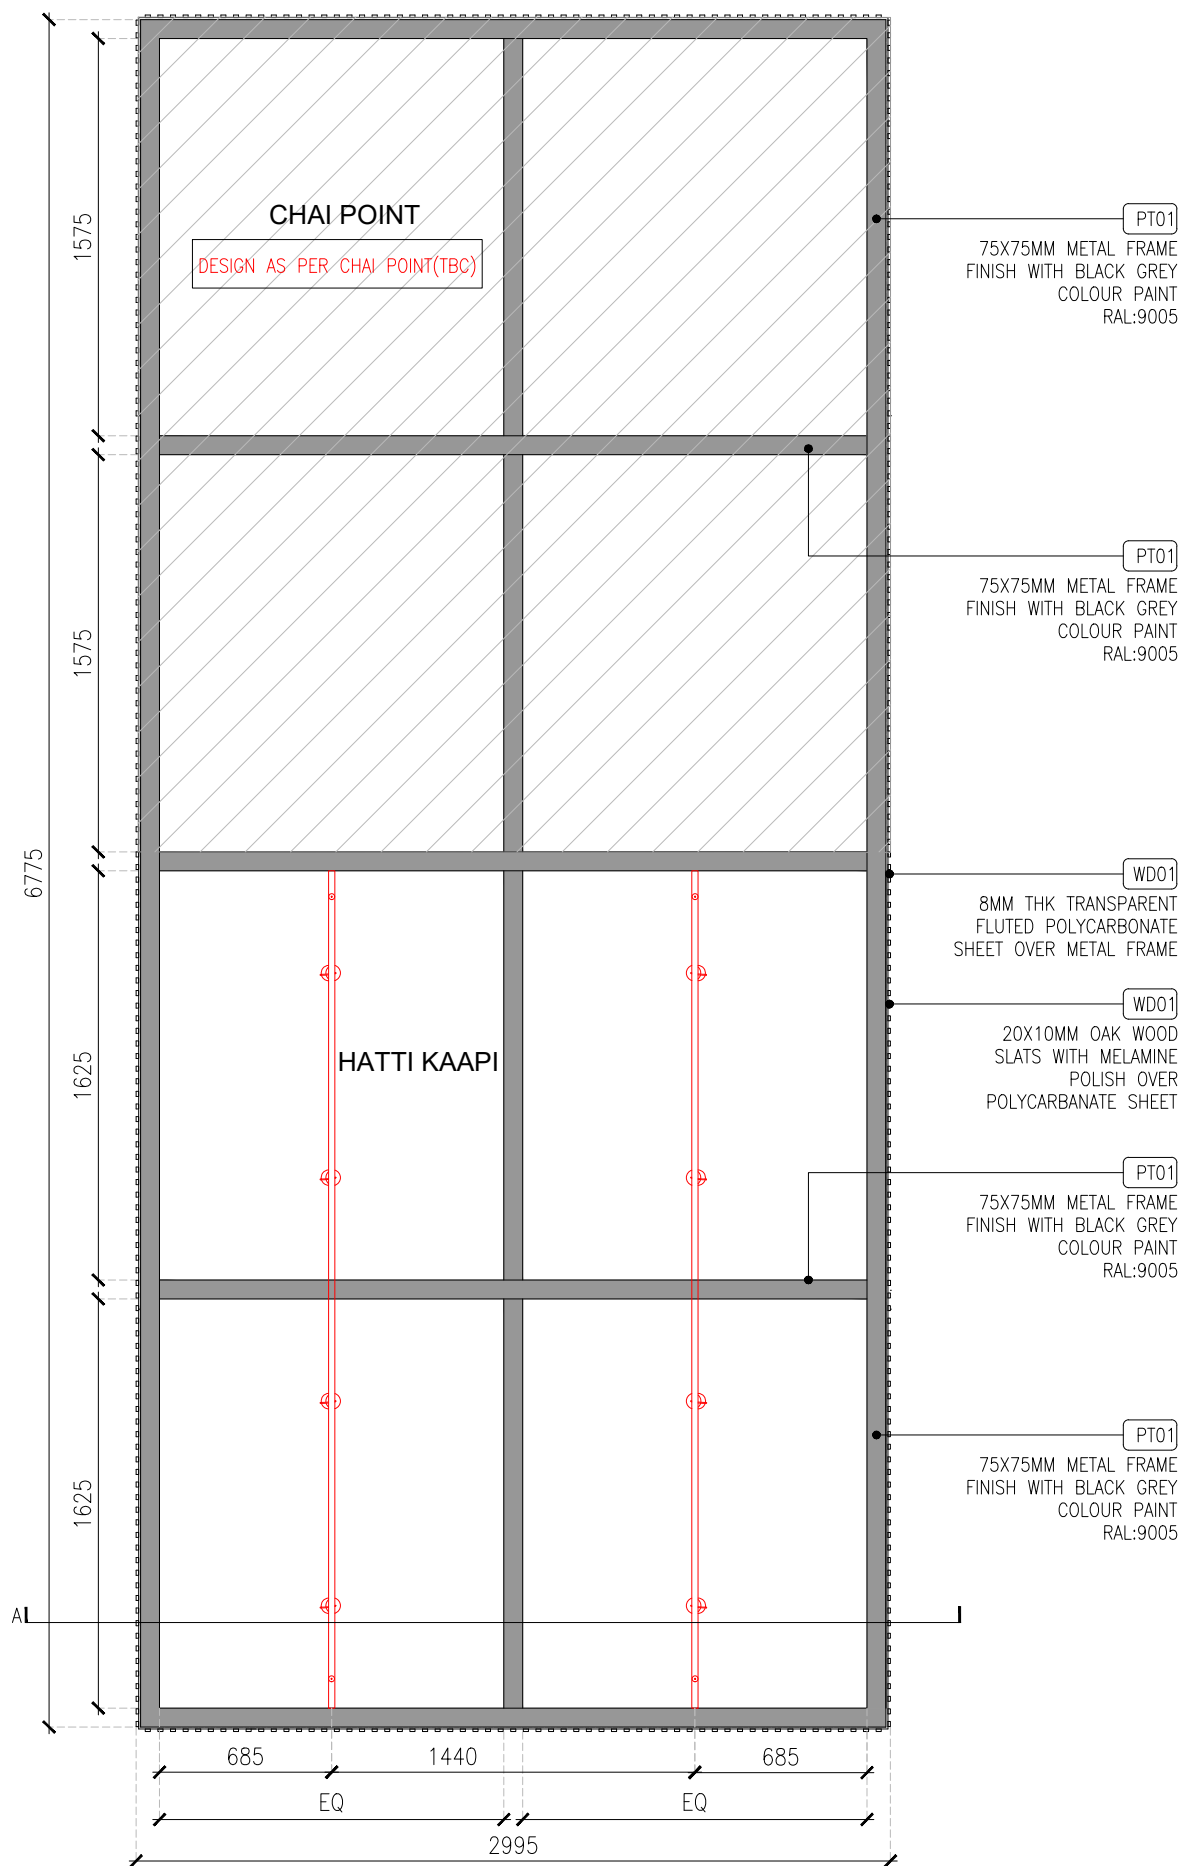

SECTION - A(SCALE 1:25)

LIGHT LEGEND				
SYMBOL	CODE	DESCRIPTION	IMAGE	COUNT
	LT01	TRACK LIGHT LIGHT TEMP:3000K		08

TO1	02.02.24	TENDER	HOD	NM
REV	DATE	DESCRIPTION	DRN	CHK



PROJECT
HATTI KAAPi FF52
GMR INTERNATIONAL
AIRPORT LIMITED,
HYDERABAD


DRAWING TITLE
RCP+LIGHTING LAYOUT

SCALE AS MENTIONED DATE: 02.02.2024 DRAWN HOD: A3 SHEET


STATUS
TENDER

ORG	PROJECT NO	DRAWING TYPE	NUMBER	REV
TFS	XXXX	02GA	103	T01

01 RCP+LIGHTING LAYOUT
 02GA-103 1:30

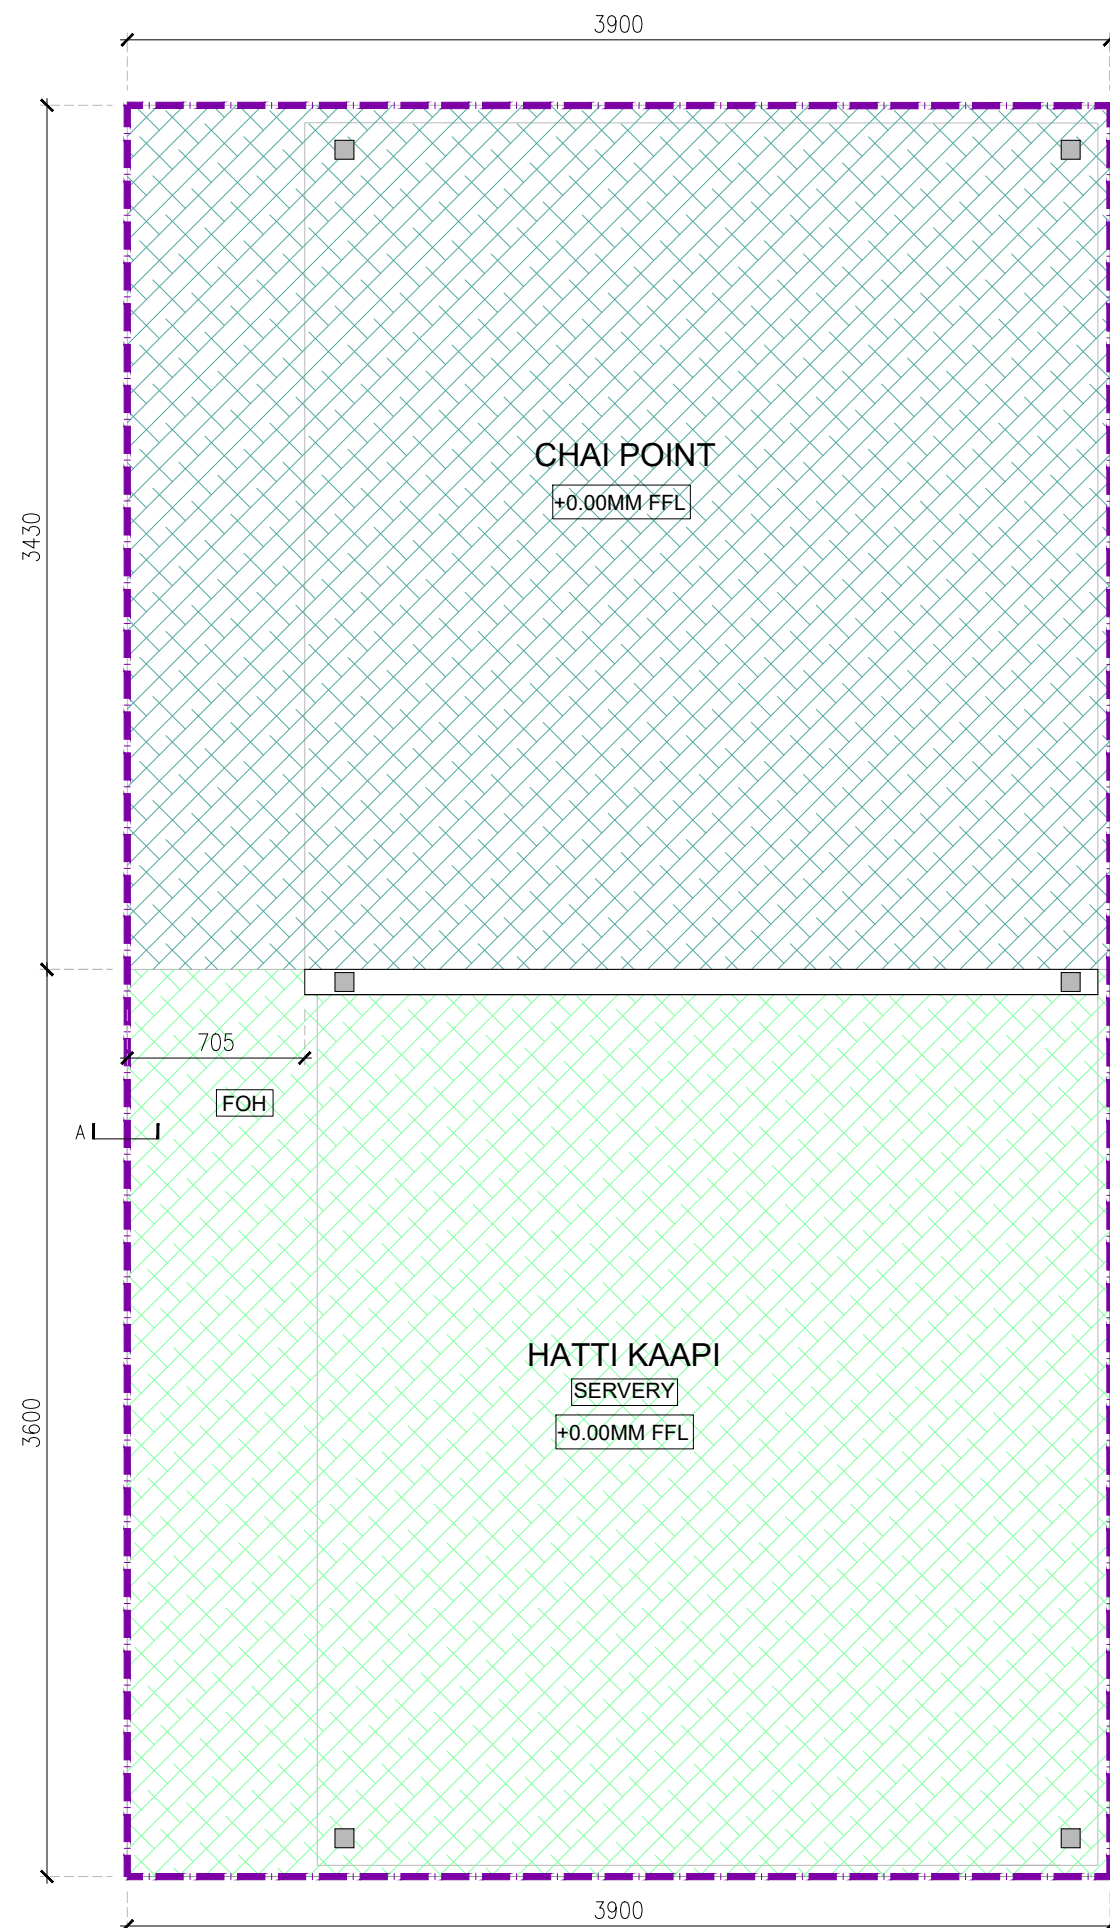

FLOORING LEGEND					
SL.NO	CODE	PATTERN	DESCRIPTION	AREA/LENGTH	
01	FL01		600x600MM GREY COLOR KOTA STONE(HATTI KAPPI)	13.71M ²	
			600x600MM GREY COLOR KOTA STONE(CHAI POINT)	13.35M ²	
02	FL02		S.S 304 GRADE T-SHAPE TRANSITION TRIM	HATTI KAPPI	11.09Mtr
				CHAI POINT	10.75Mtr

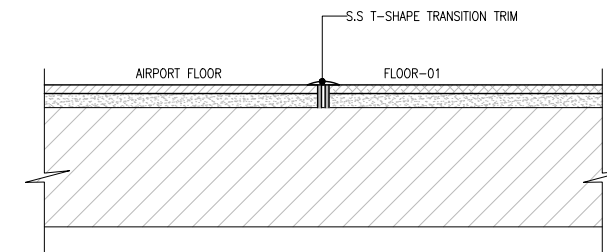

TYPICAL FLOOR TRANSITION DETAIL
SECTION-A(SCALE 1:10)

T01 29.01.24 TENDER HOD NM
REV DATE DESCRIPTION DRN CHK



PROJECT
HATTI KAAPi FF52
GMR INTERNATIONAL
AIRPORT LIMITED,
HYDERABAD

DRAWING TITLE
FLOORING LAYOUT

SCALE AS MENTIONED DATE 02.02.2024 DRAWN HOD A3 SHEET




STATUS
TENDER

ORG PROJECT NO DRAWING TYPE NUMBER REV
TFS XXXX 02GA 104 T01



TOTAL AREA OF HATTI KAAPI
TO BE WATER PROOFED
= 10.67 M²

TOTAL AREA OF CHAI POINT
TO BE WATER PROOFED
= 10.56 M²

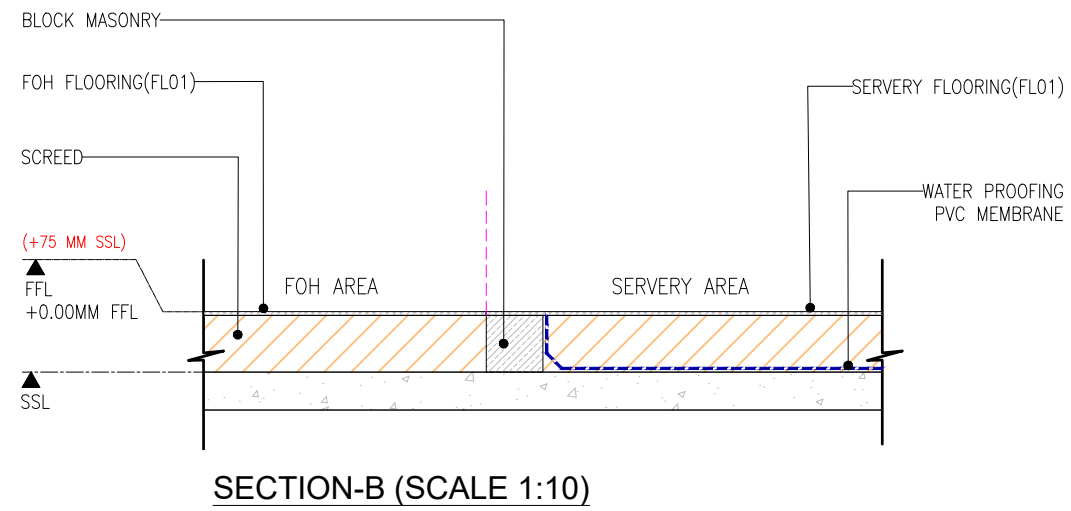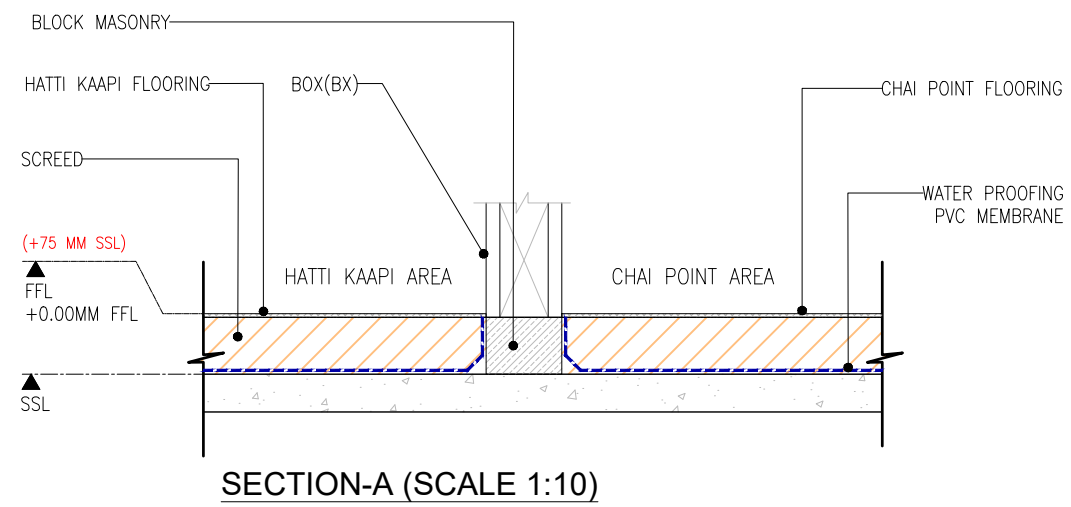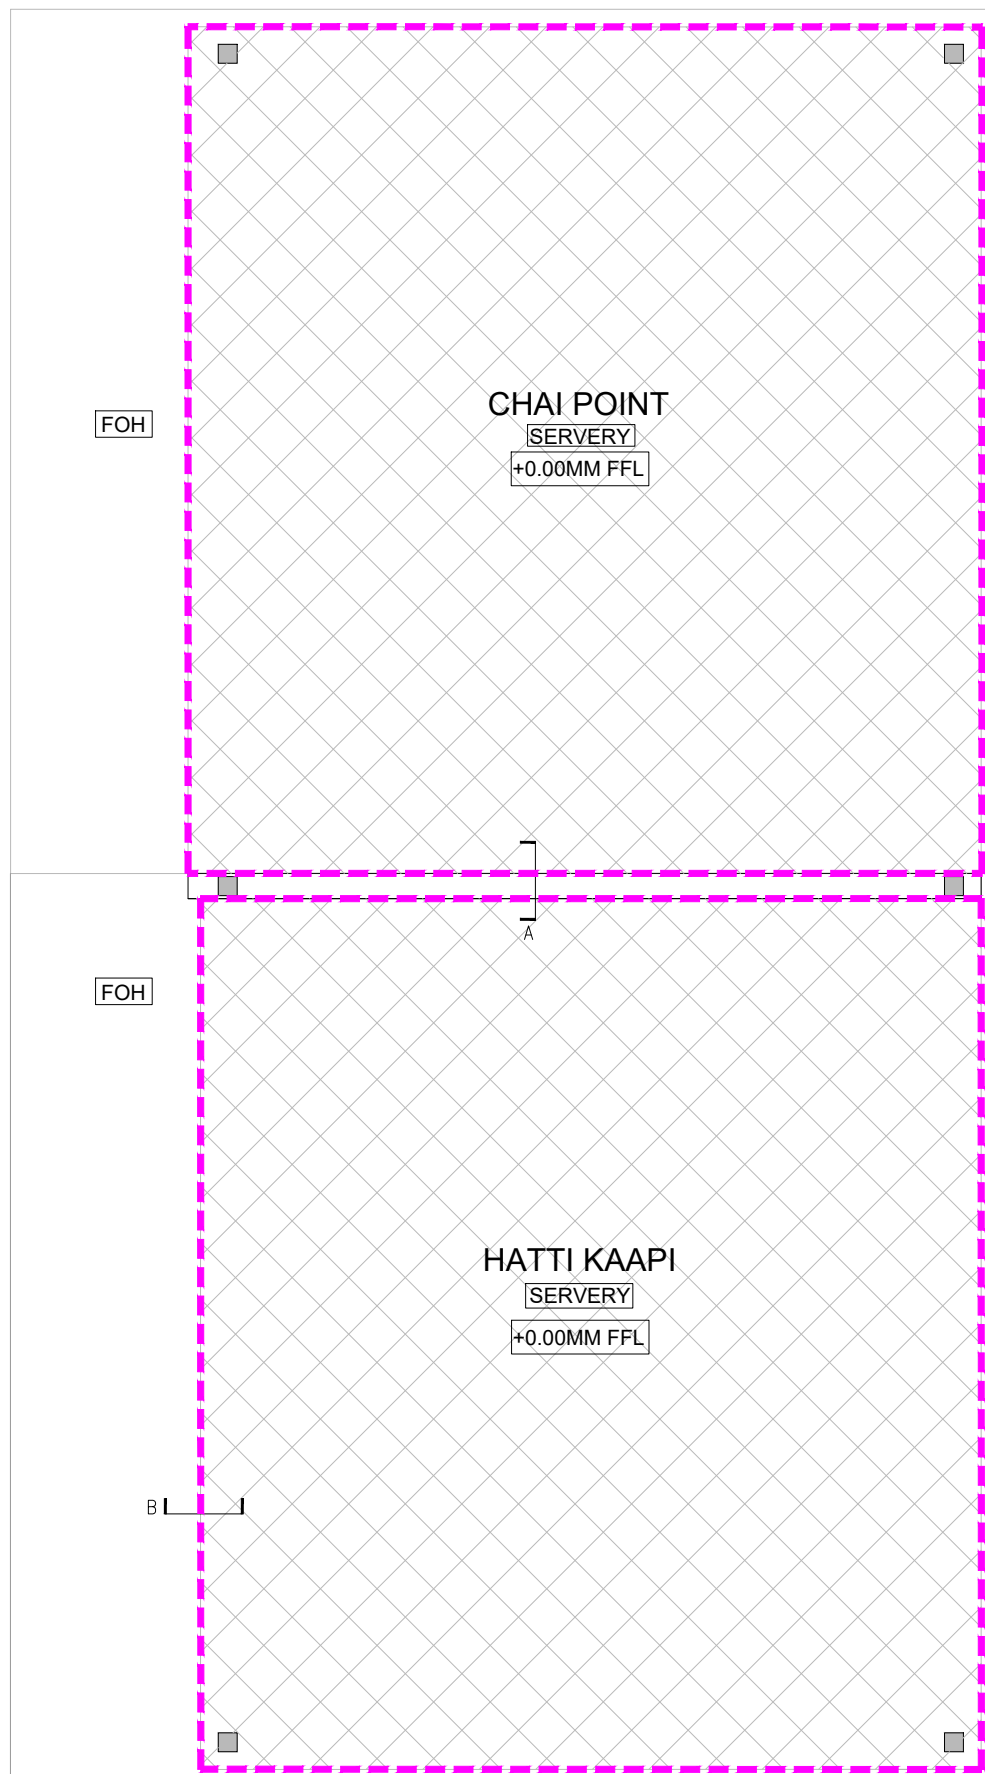

REV	DATE	DESCRIPTION	HOD	NM
TO1	02.02.24	TENDER		
			DRN	CHK




PROJECT
HATTI KAAPI FF52
GMR INTERNATIONAL
AIRPORT LIMITED,
HYDERABAD

DRAWING TITLE
WATER PROOFING LAYOUT

SCALE AS MENTIONED DATE 02.02.2024 DRAWN HOD A3 SHEET

STATUS
TENDER

ORG	PROJECT NO	DRAWING TYPE	NUMBER	REV
TFS	XXXX 02GA	105	T01	

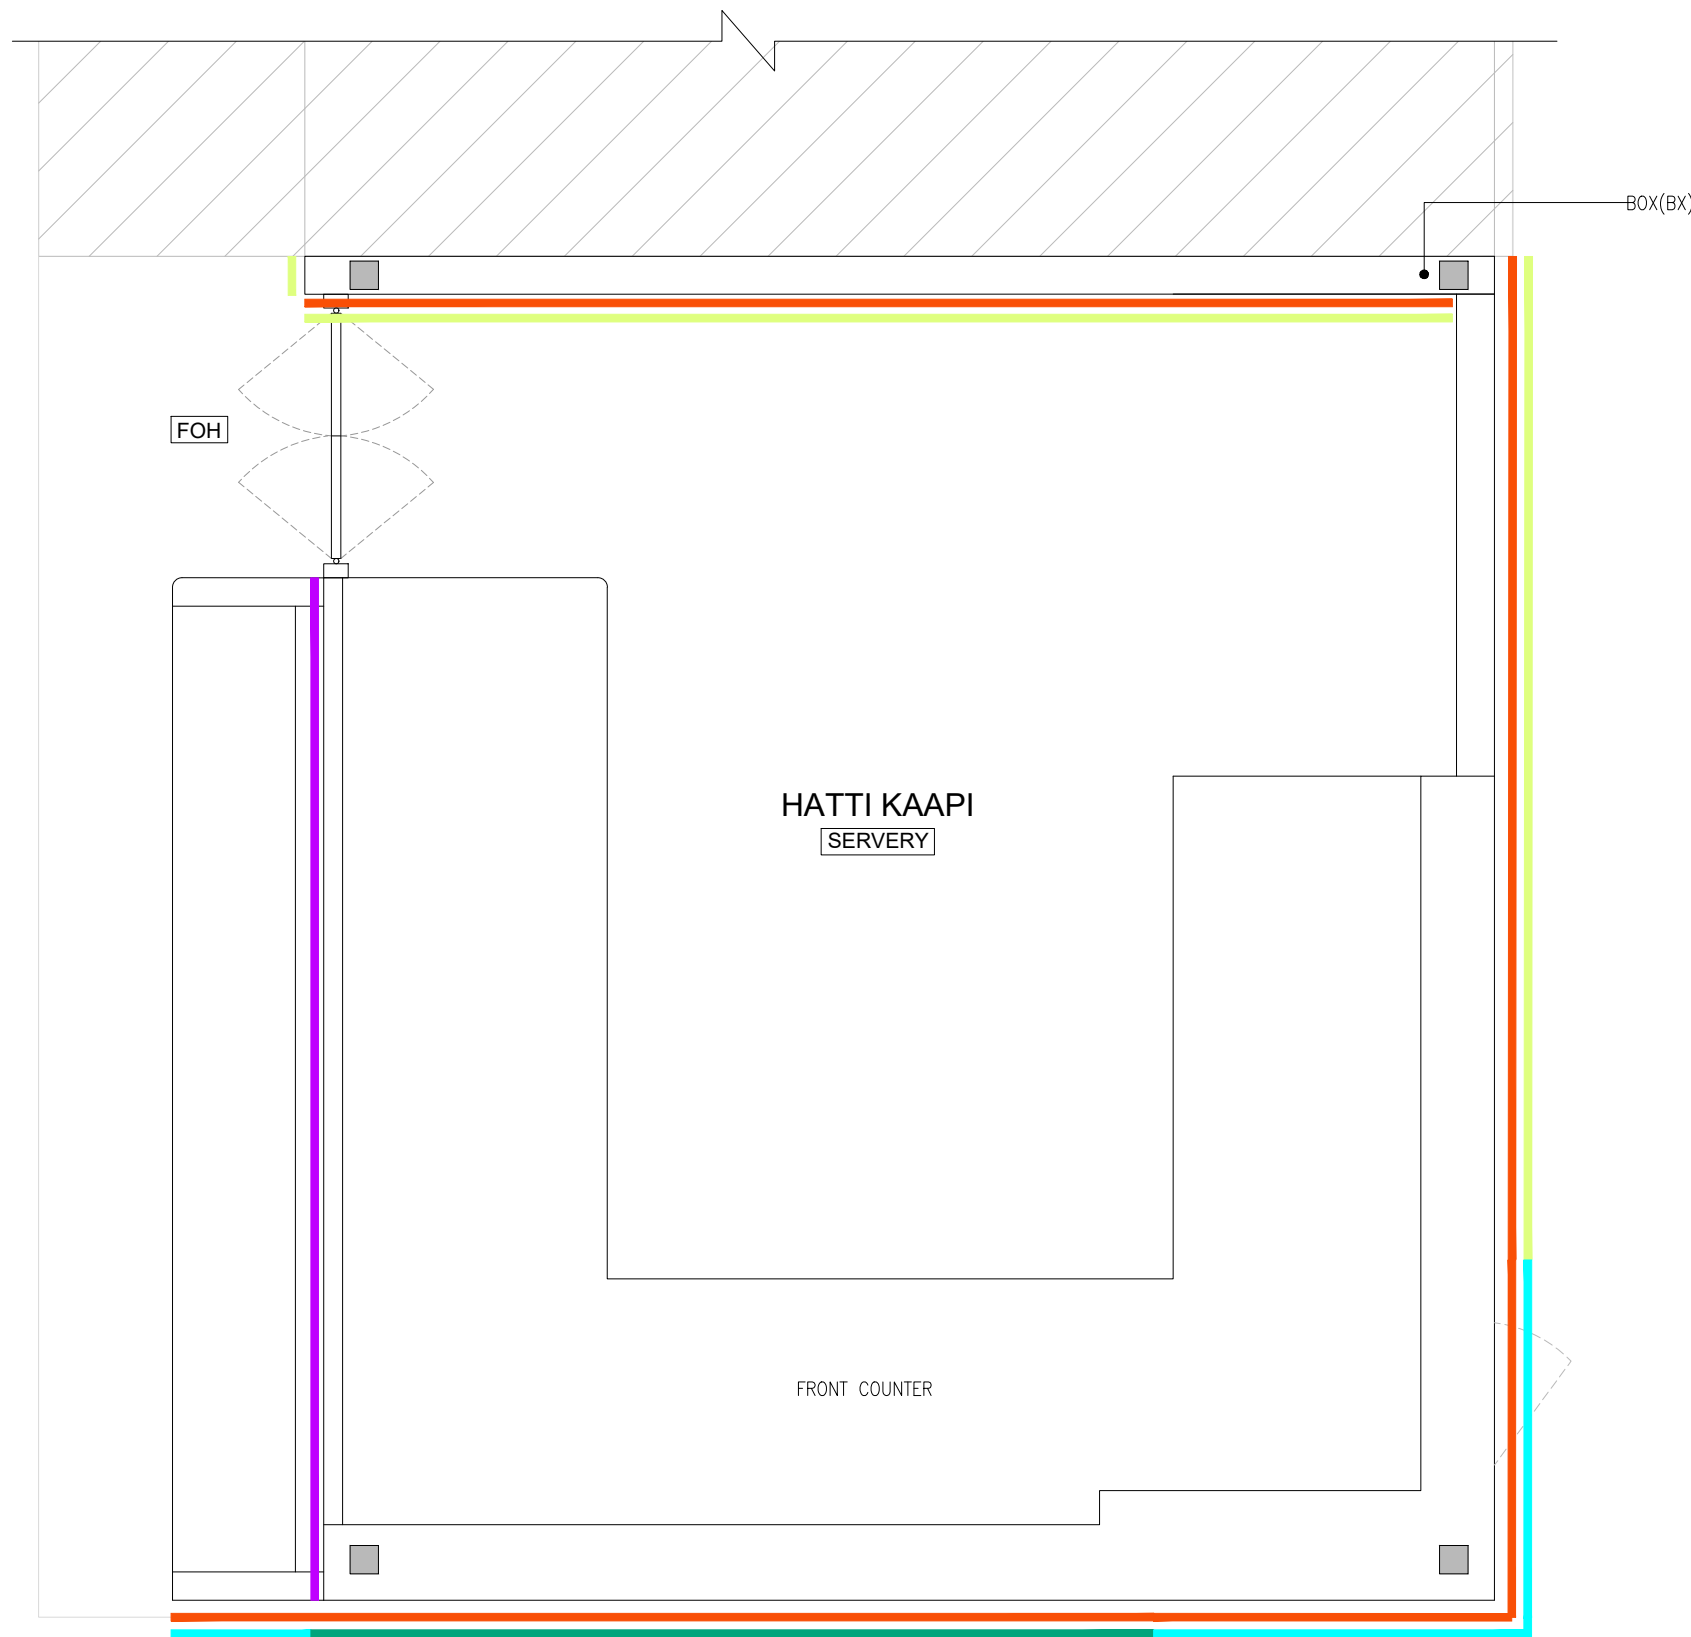

FINISHES LEGEND		
SYMBOL	FINISH	SURFACE
	WD02 20X20MM OAK WOOD SLATS WITH CLEAR PU FINISH	FRONT COUNTER
	PT01 GREY COLOUR PAINT GREY HARE-N COLOUR CODE:K295	FRONT COUNTER &BOX
	PT03 WHITE COLOUR PAINT ABSOLUTE WHITE COLOUR CODE:L161	FRONT COUNTER
	LM01 PARIA OAK WOOD LAMINATE	LEDGE & BOX

01 FINISHES PLAN
02GA-106 1:30

REV	DATE	DESCRIPTION	HOD	NM
			DRN	CHK





PROJECT
HATTI KAAPi FF52
GMR INTERNATIONAL
AIRPORT LIMITED,
HYDERABAD

DRAWING TITLE
FINISHES PLAN


SCALE 1:20 DATE 02.02.2024 DRAWN HOD A3 SHEET

STATUS
TENDER

ORG	PROJECT NO	DRAWING TYPE	NUMBER	REV
TFS	XXXX	02GA	106	T01

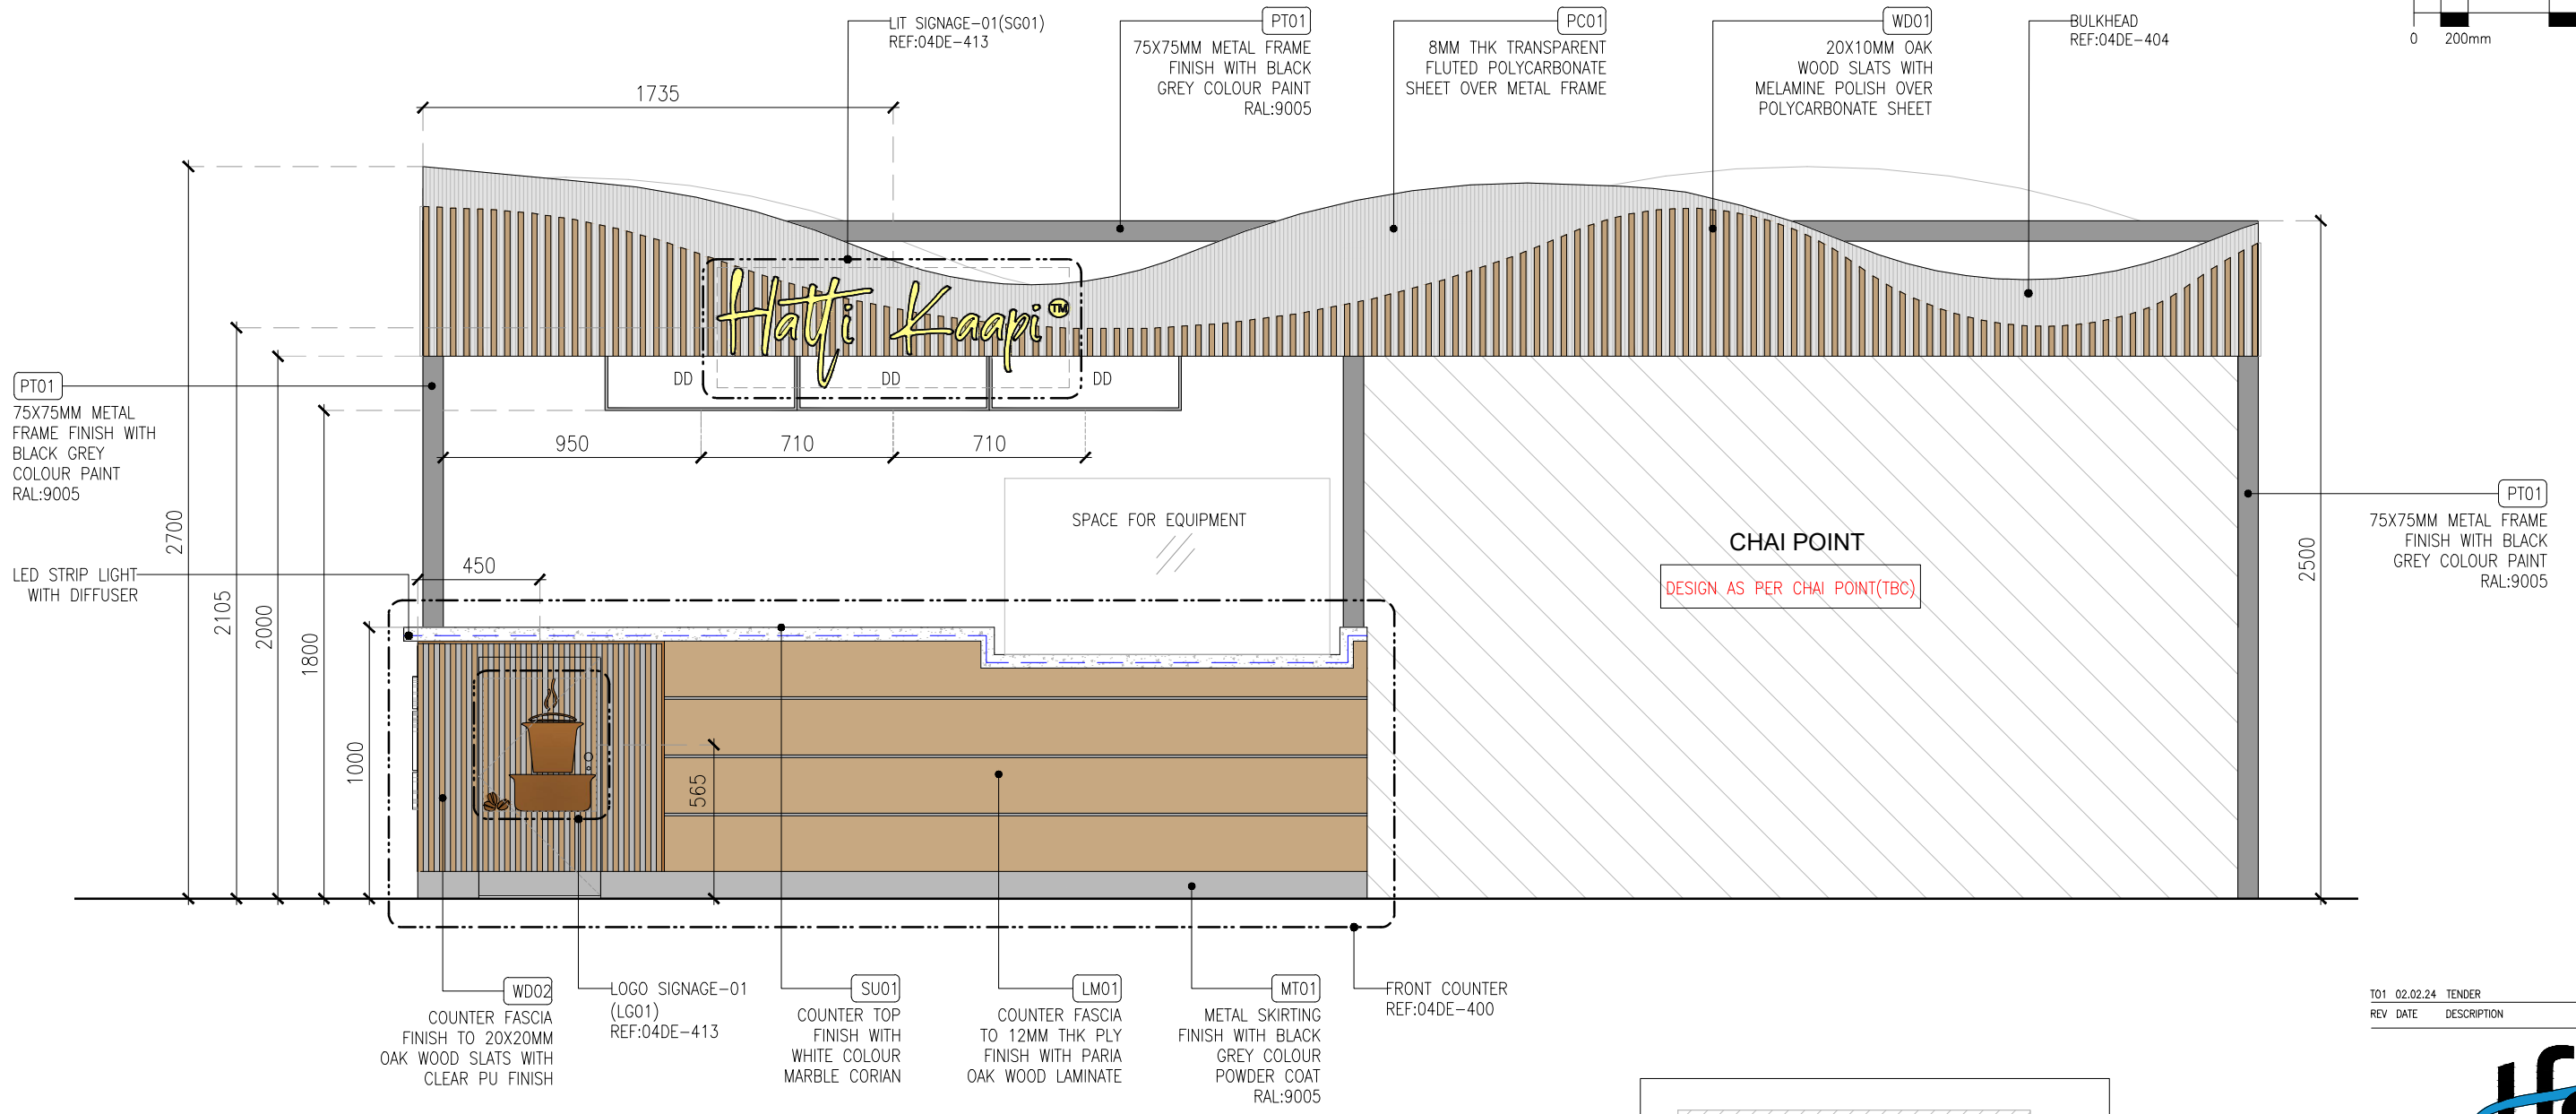 

01 ELEVATION-01
03IL-300 1:25

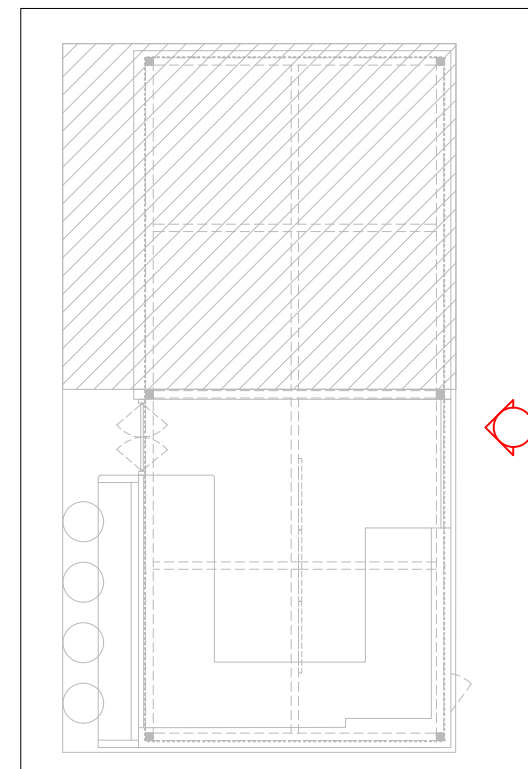

KEY PLAN

PROJECT NO	02.02.24	TENDER	HOD NM
REV DATE		DESCRIPTION	DRN CHK



PROJECT
HATTI KAAPI FF52
GMR INTERNATIONAL
AIRPORT LIMITED,
HYDERABAD



DRAWING TITLE
ELEVATION-01

SCALE	1:25	DATE	02.02.2024	DRAWN HOD	A3 SHEET
-------	------	------	------------	-----------	----------

STATUS

TENDER

ORG	PROJECT NO	DRAWING TYPE	NUMBER	REV
TFS	XXXX 03IL	300	T01	

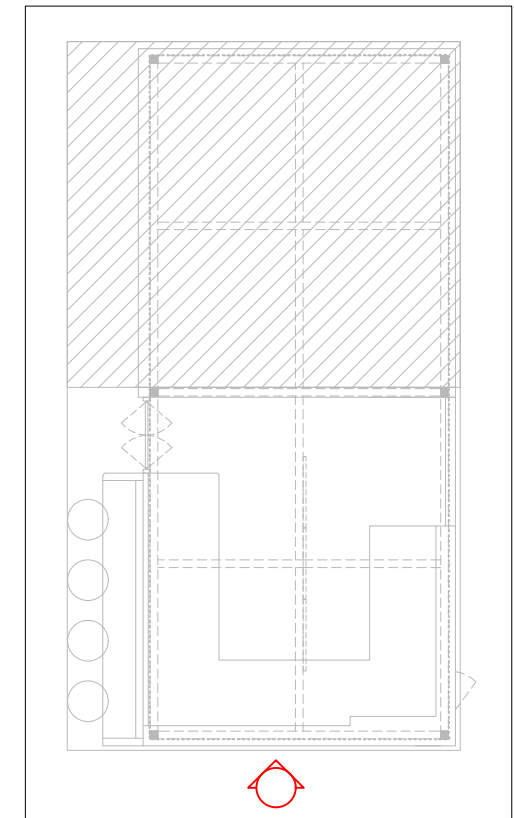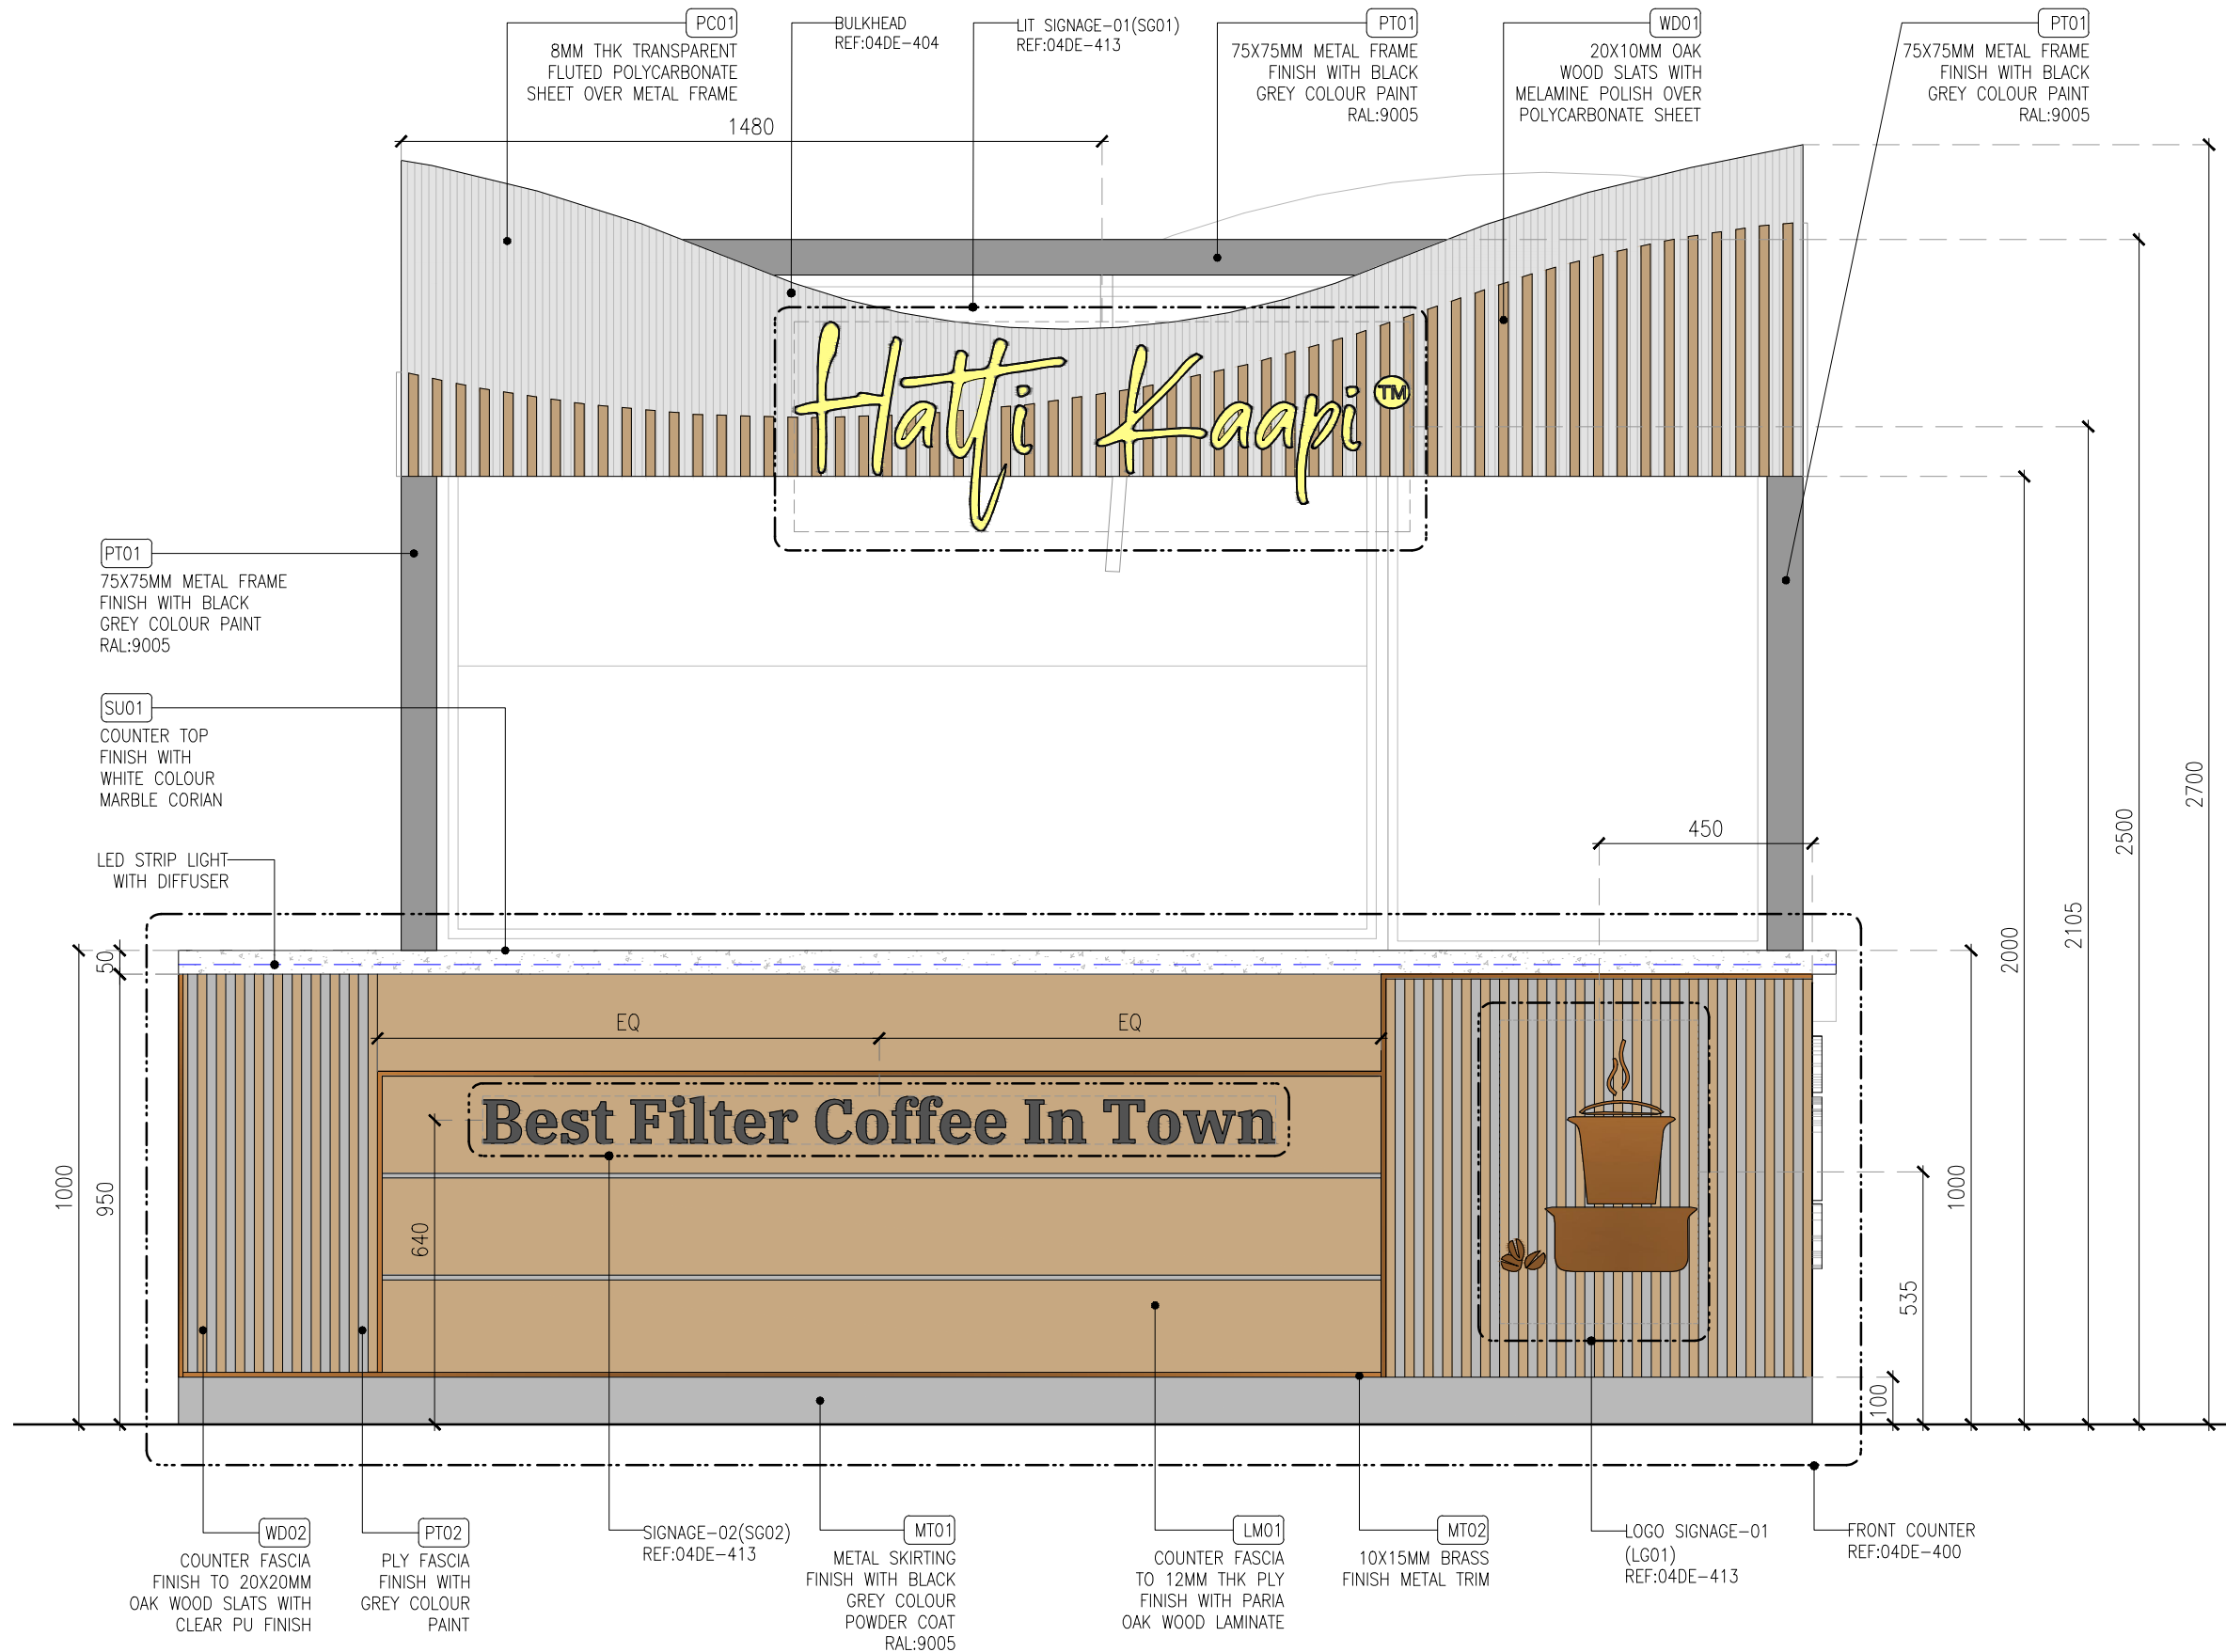

KEY PLAN

REV	DATE	DESCRIPTION	HOD	NM	DRN	CHK
T01	02.02.24	TENDER				



PROJECT
HATTI KAAPU FF52
GMR INTERNATIONAL
AIRPORT LIMITED,
HYDERABAD





DRAWING TITLE
ELEVATION-02

SCALE 1:15 DATE 02.02.2024 DRAWN HOD A3 SHEET

STATUS
TENDER

ORG	PROJECT NO	DRAWING TYPE	NUMBER	REV
TFS	XXXX 03IL	301	T01	

01 ELEVATION-02
03IL-301 1:15

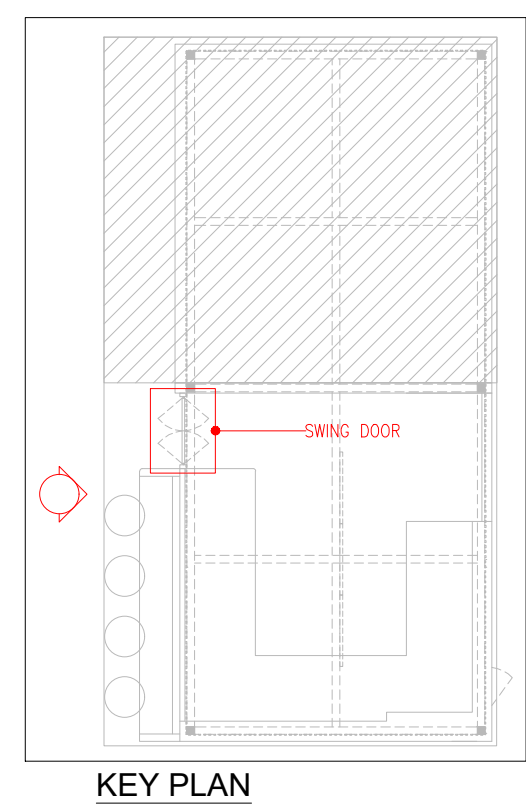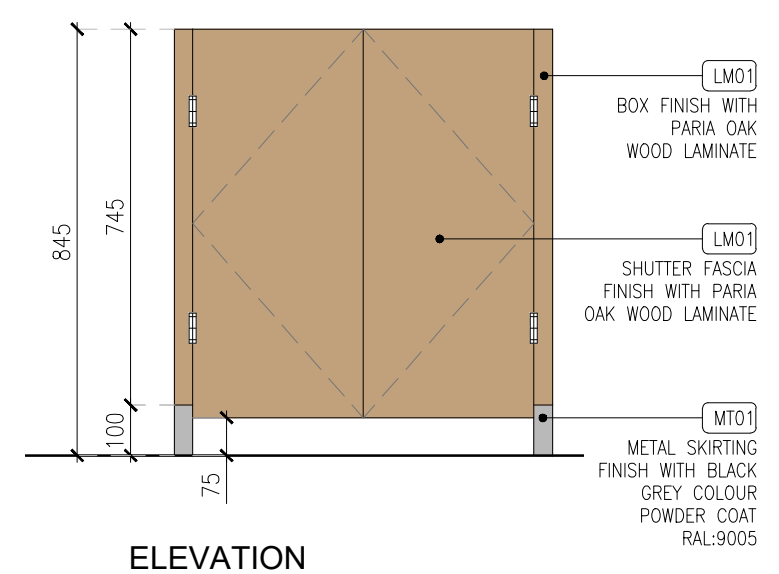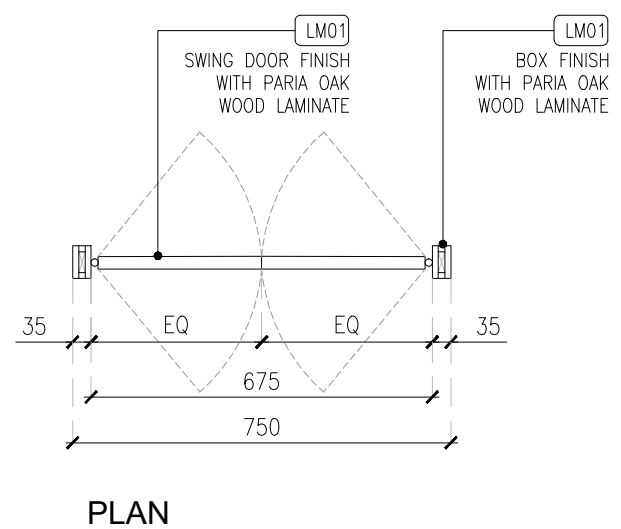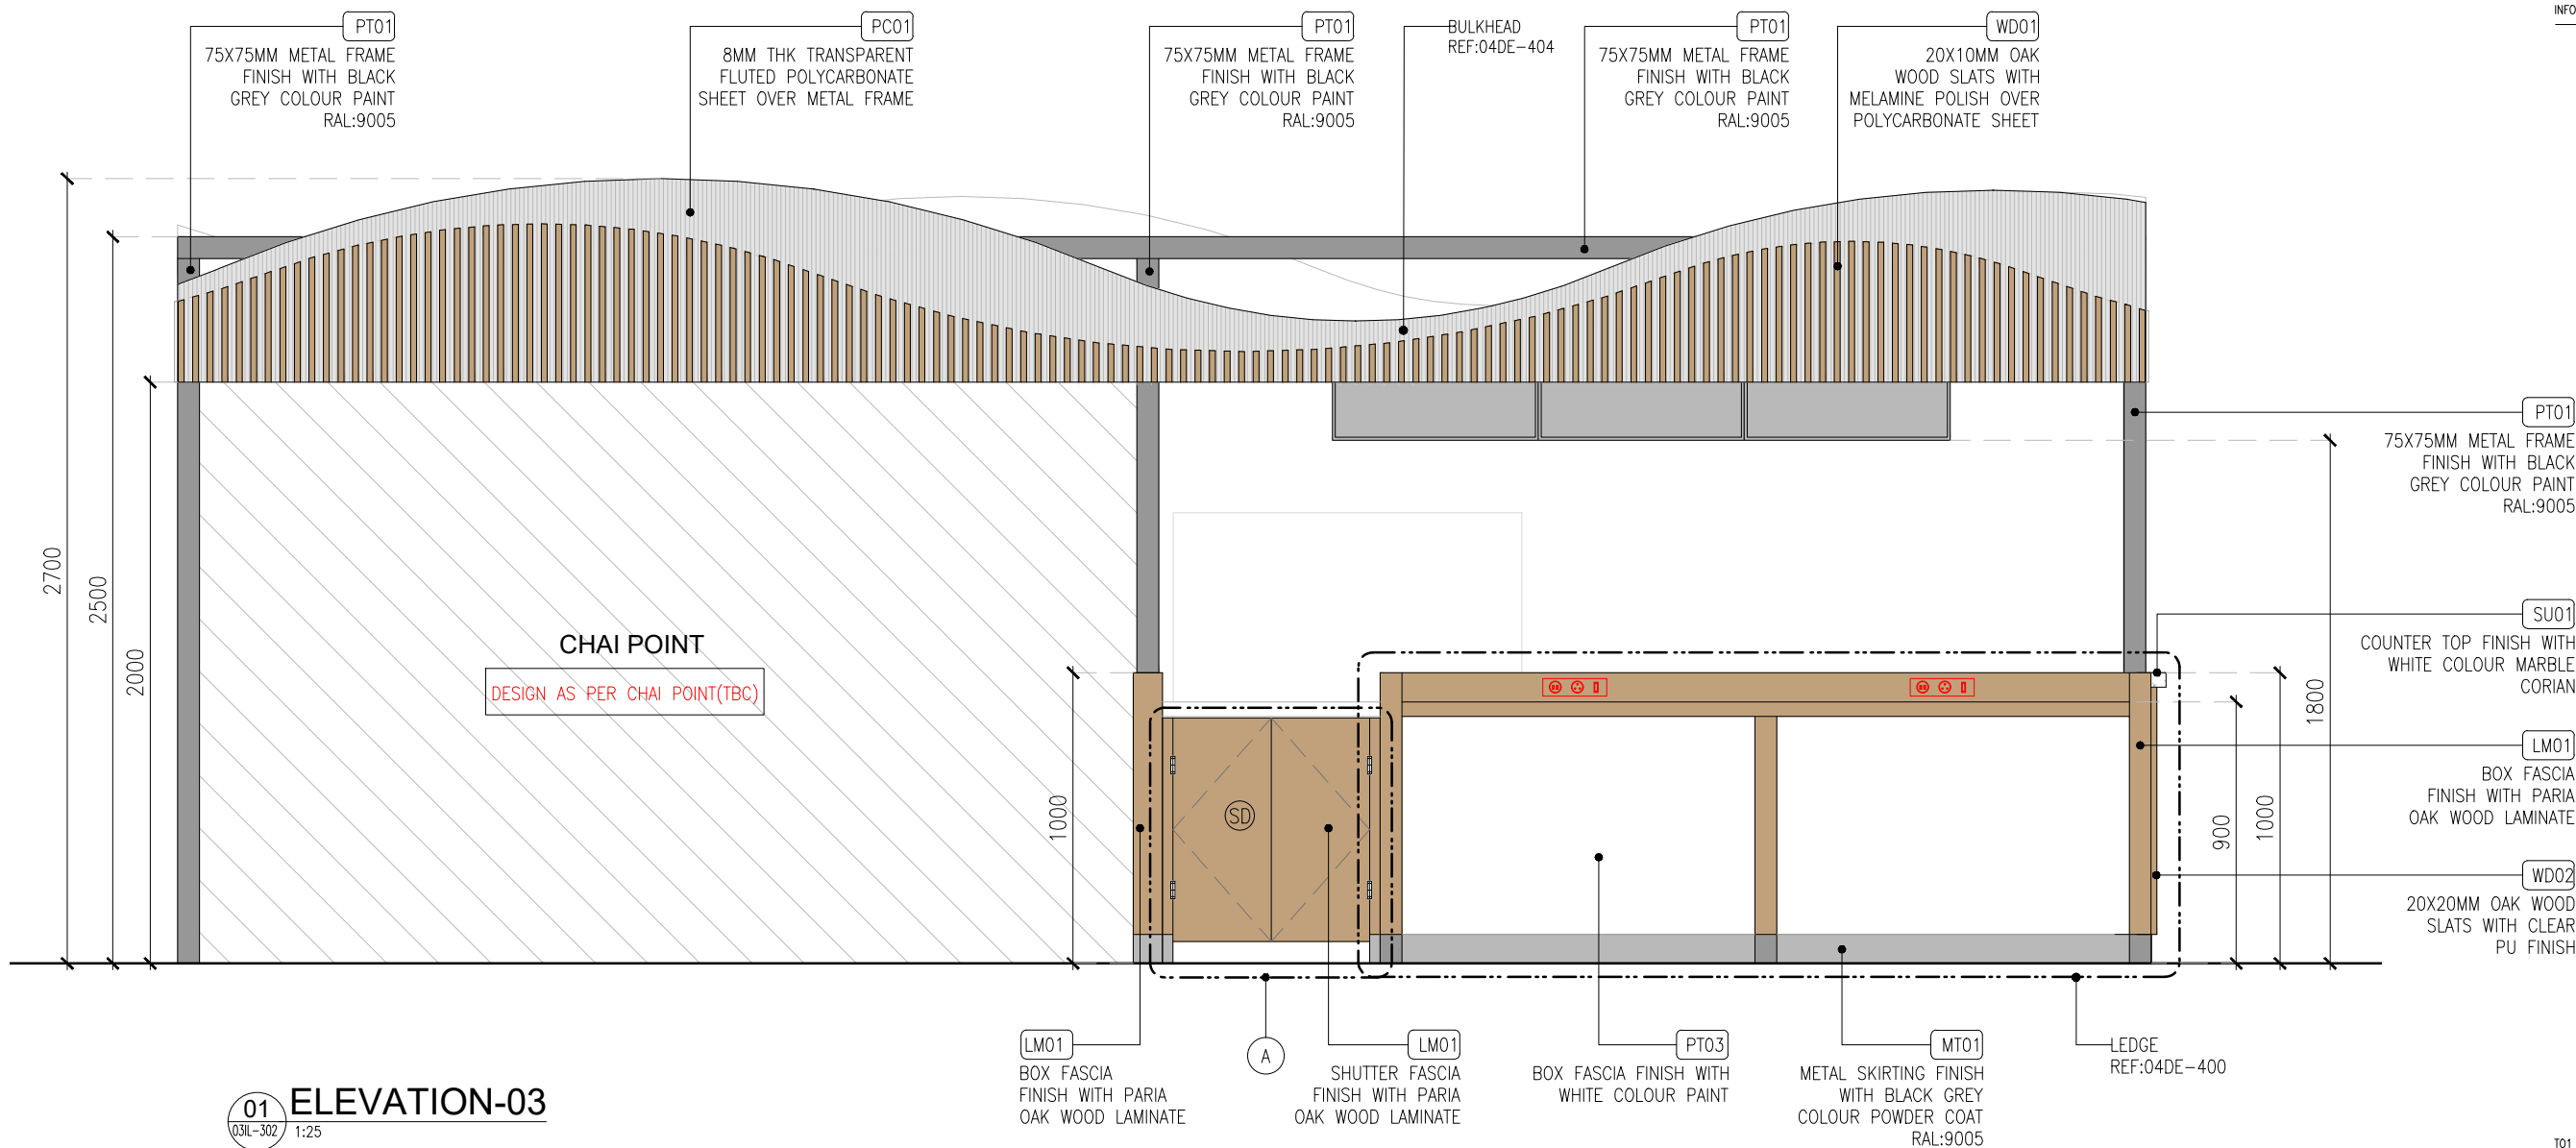

T01	02.02.24	TENDER		HOD	NM
REV	DATE	DESCRIPTION		DRN	CHK



PROJECT
HATTI KAAPI FF52
GMR INTERNATIONAL
AIRPORT LIMITED,
HYDERABAD



DRAWING TITLE
ELEVATION-03 &
J04-SWING DOOR DETAIL

SCALE AS MENTIONED DATE: 02.02.2024 DRAWN HOD: A3 SHEET

STATUS
TENDER

ORG	PROJECT NO	DRAWING TYPE	NUMBER	REV
TFS	XXXX 03IL	302	T01	

02 J04-SWING DOOR DETAIL-A
03IL-302 1:15

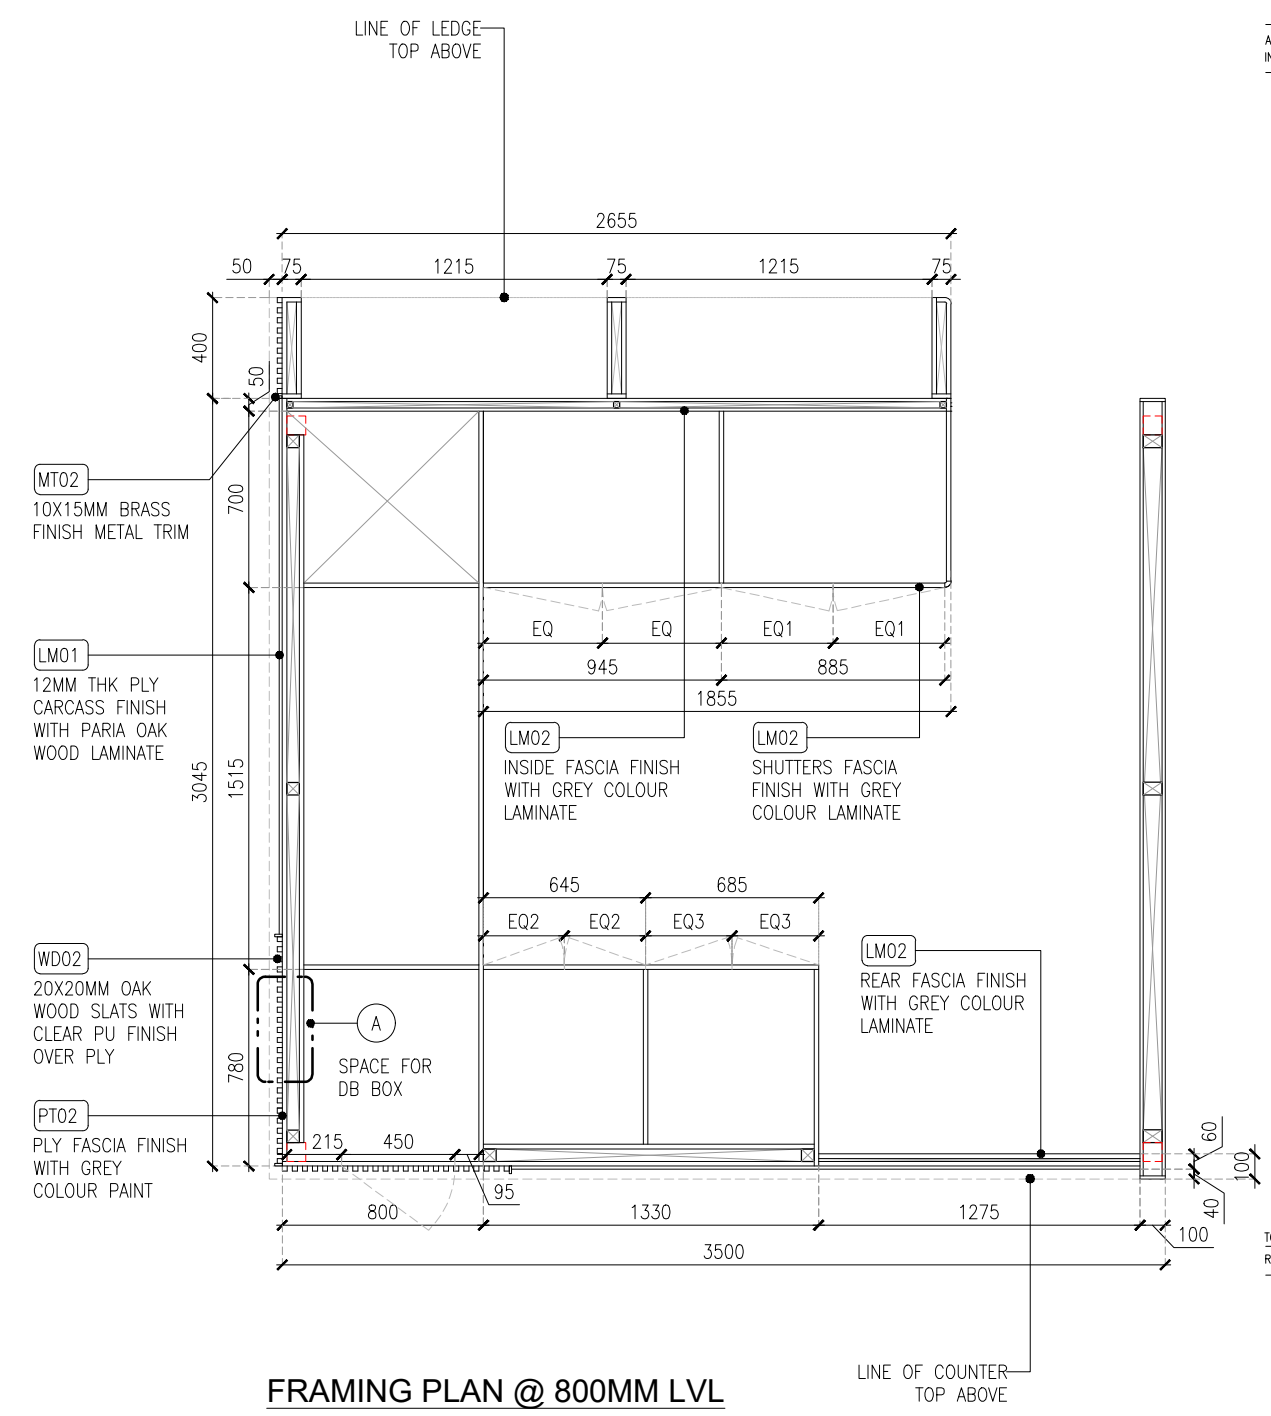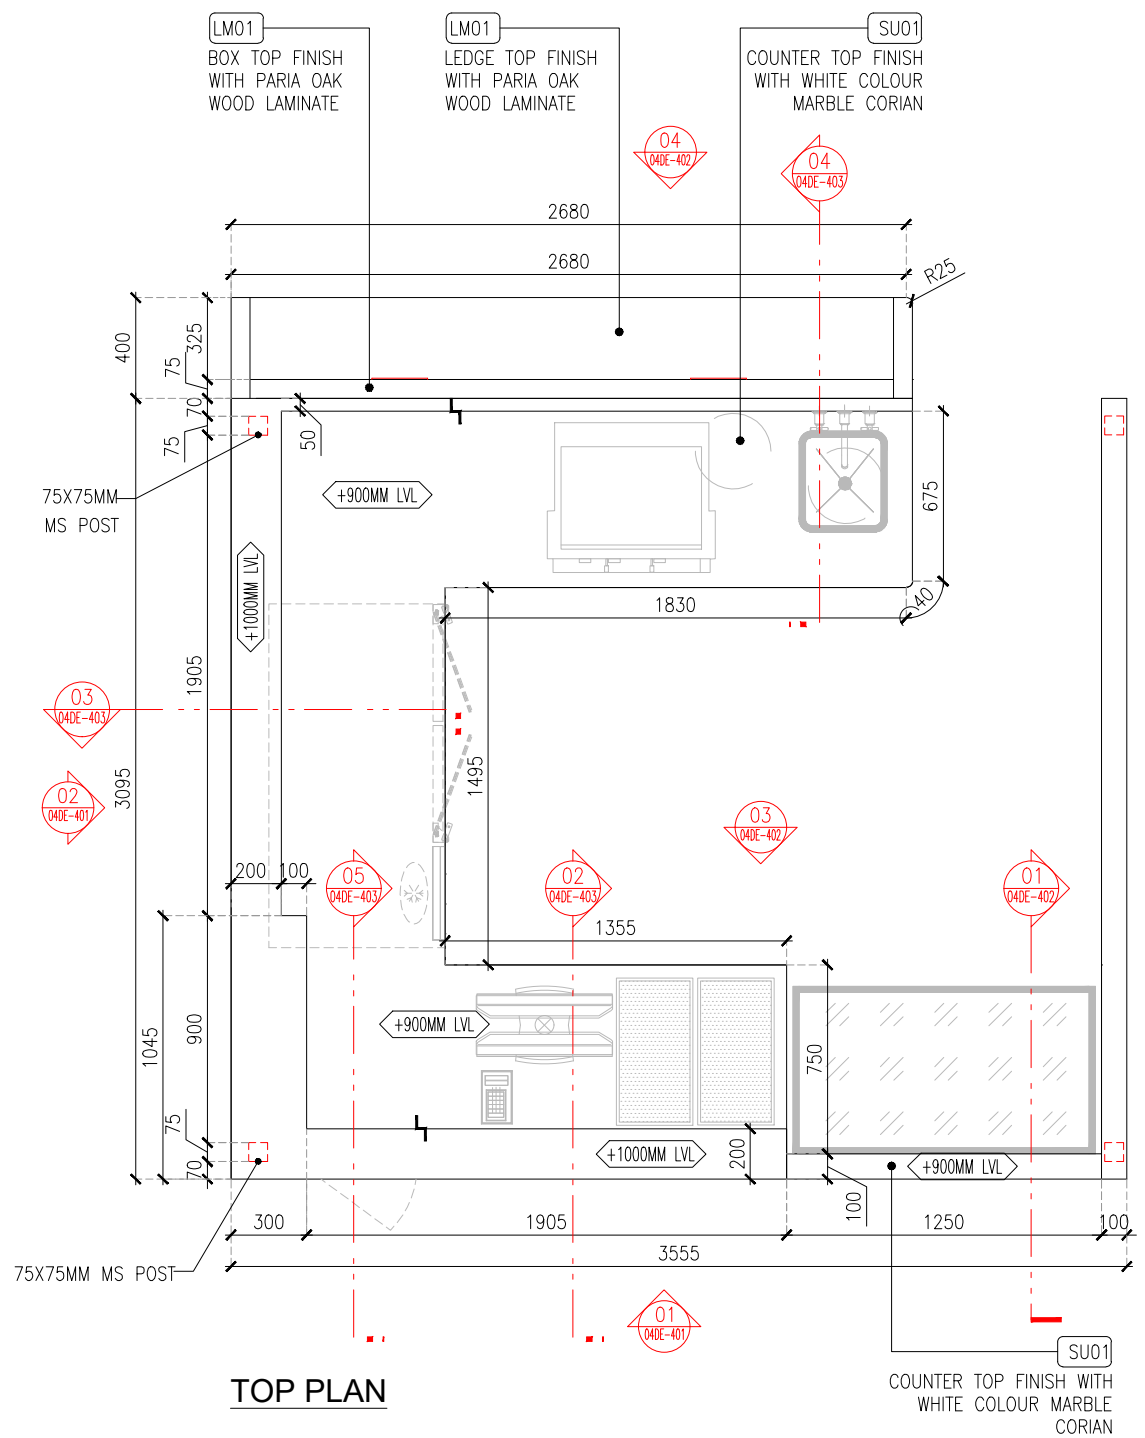

TO1	02.02.24	TENDER	HOD	NM
REV	DATE	DESCRIPTION	DRN	CHK



PROJECT
HATTI KAAPI FF52
GMR INTERNATIONAL
AIRPORT LIMITED,
HYDERABAD



DRAWING TITLE
J01&J02 -FRONT COUNTER & LEDGE DETAIL PART-A



SCALE AS MENTIONED DATE: 02.02.2024 DRAWN HOD A3 SHEET

STATUS
TENDER

ORG PROJECT NO DRAWING TYPE NUMBER REV
TFS XXXX 04DE 400 T01


01 J01&J02-FRONT COUNTER & LEDGE DETAIL PART-A
 04DE-400 1:30

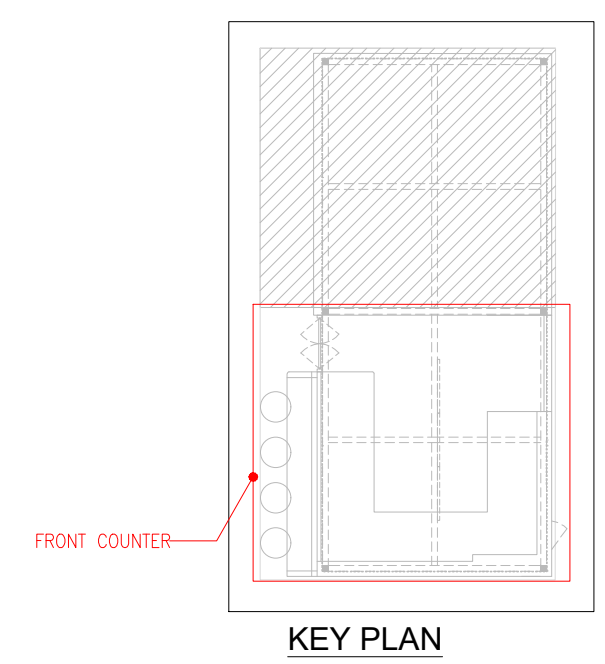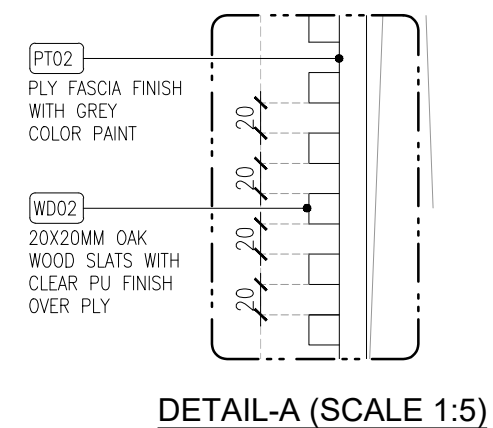

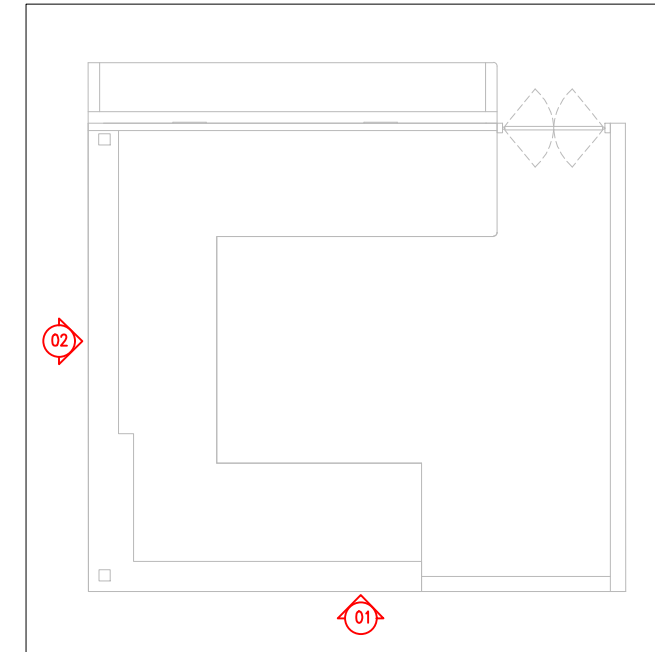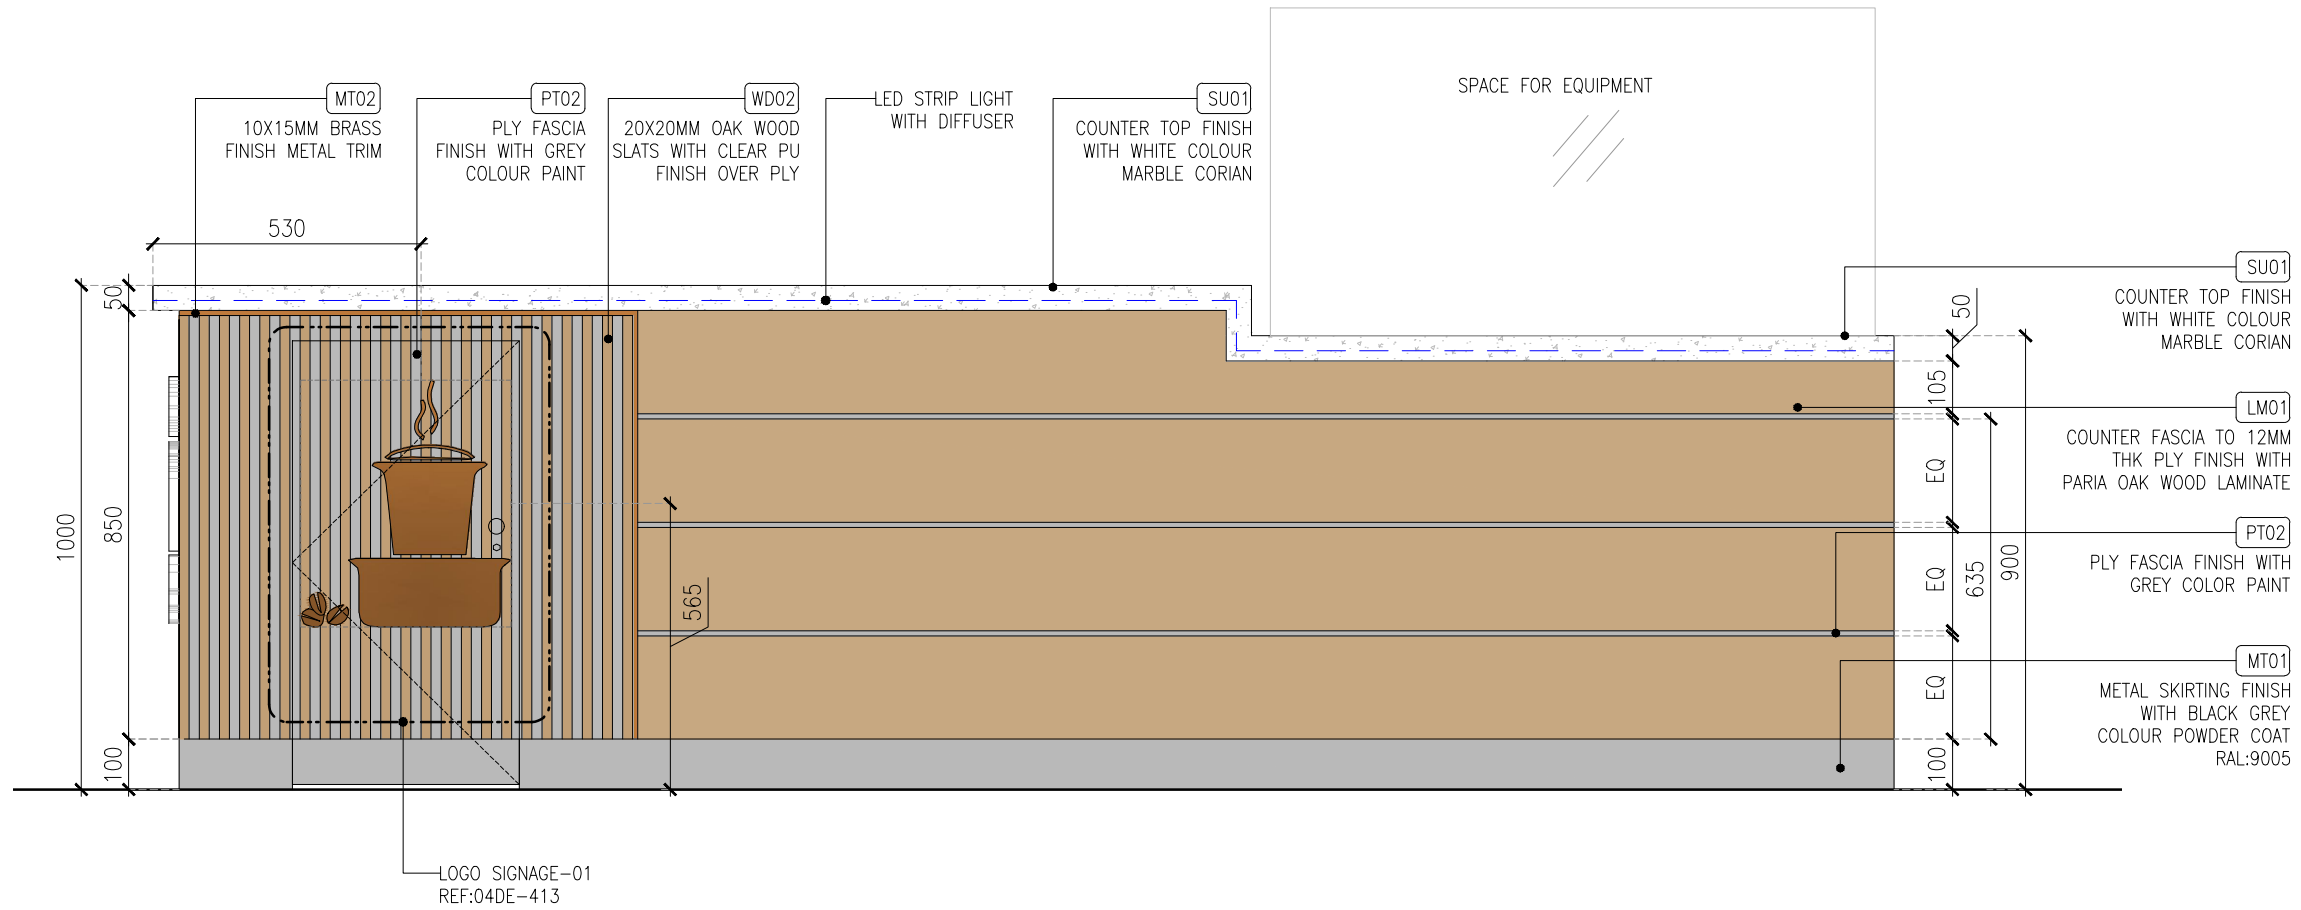

KEY PLAN

01 ELEVATION -01
04DE-401 1:15

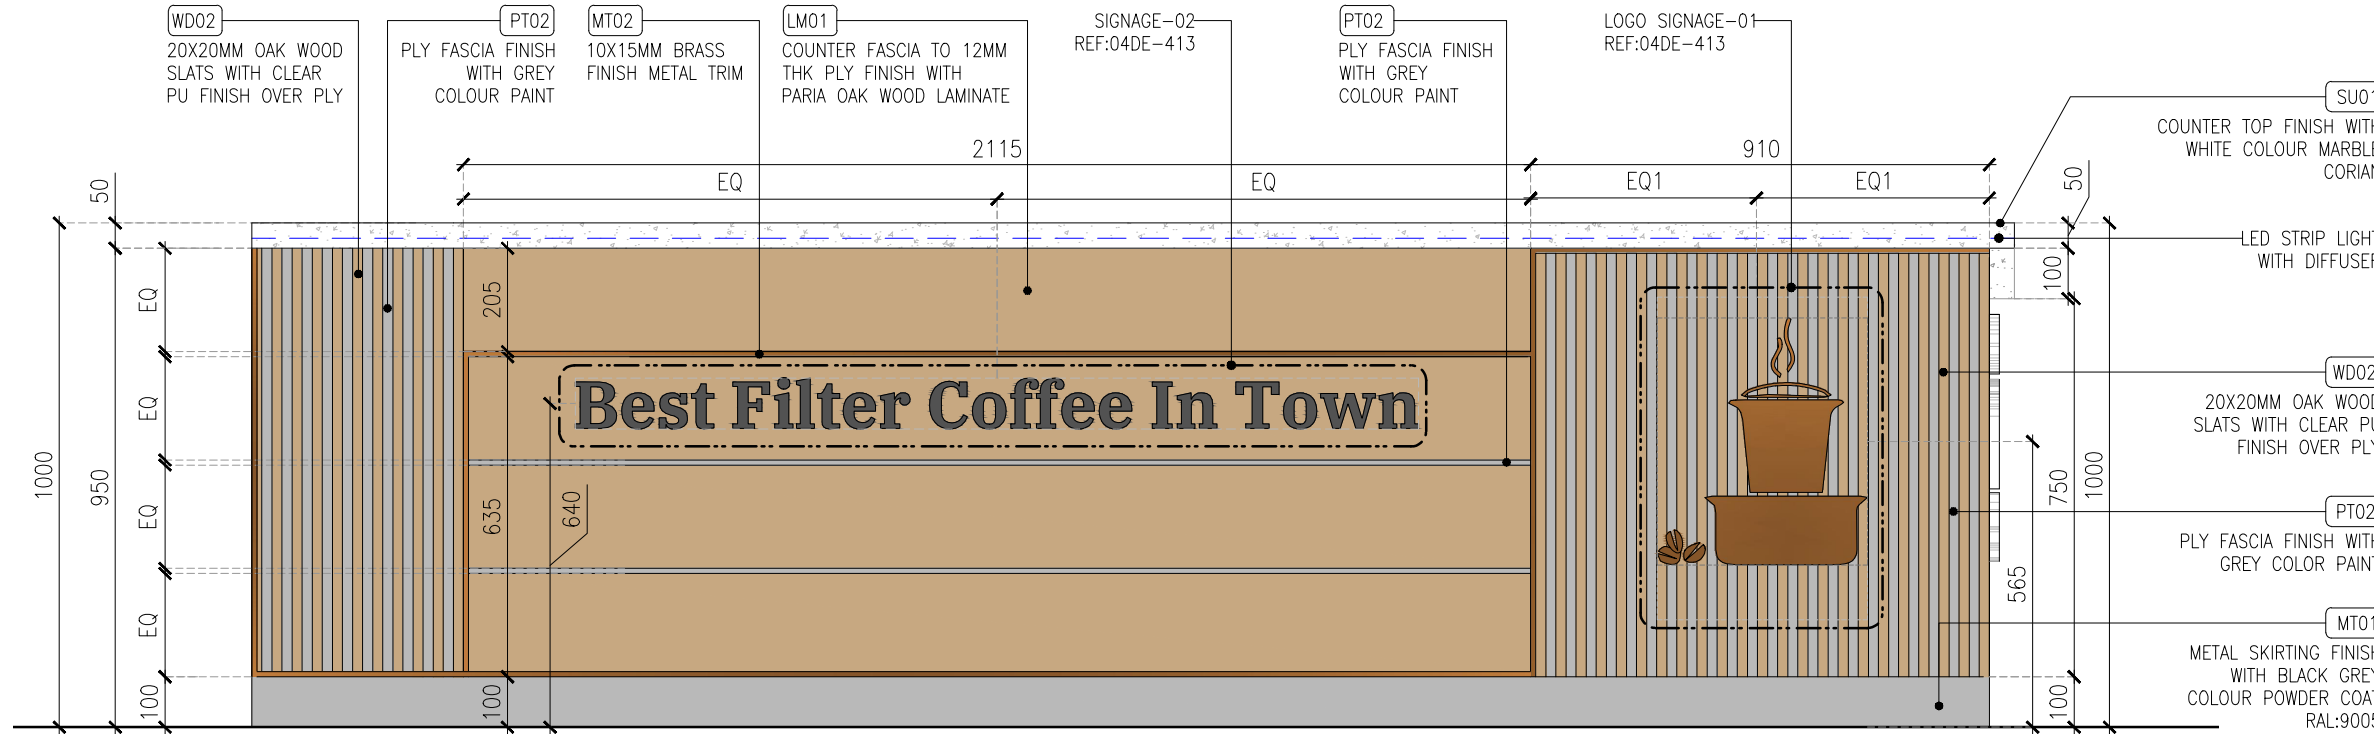

02 ELEVATION -02
04DE-401 1:15

T01	02.02.24	TENDER	HOD	NM
REV	DATE	DESCRIPTION	DRN	CHK



PROJECT
HATTI KAAPI FF52
GMR INTERNATIONAL
AIRPORT LIMITED,
HYDERABAD

DRAWING TITLE
J01&J02 -FRONT COUNTER &
LEDGE DETAIL PART-B


SCALE 1:15 DATE 02.02.2024 DRAWN HOD A3 SHEET

STATUS


TENDER

ORG	PROJECT NO	DRAWING TYPE	NUMBER	REV
TFS	XXXX	04DE	401	T01


ALL DIMENSIONS MUST BE CHECKED ON SITE.
INFORM THE ENGINEER OF ANY DISCREPANCIES PRIOR TO CONSTRUCTION.

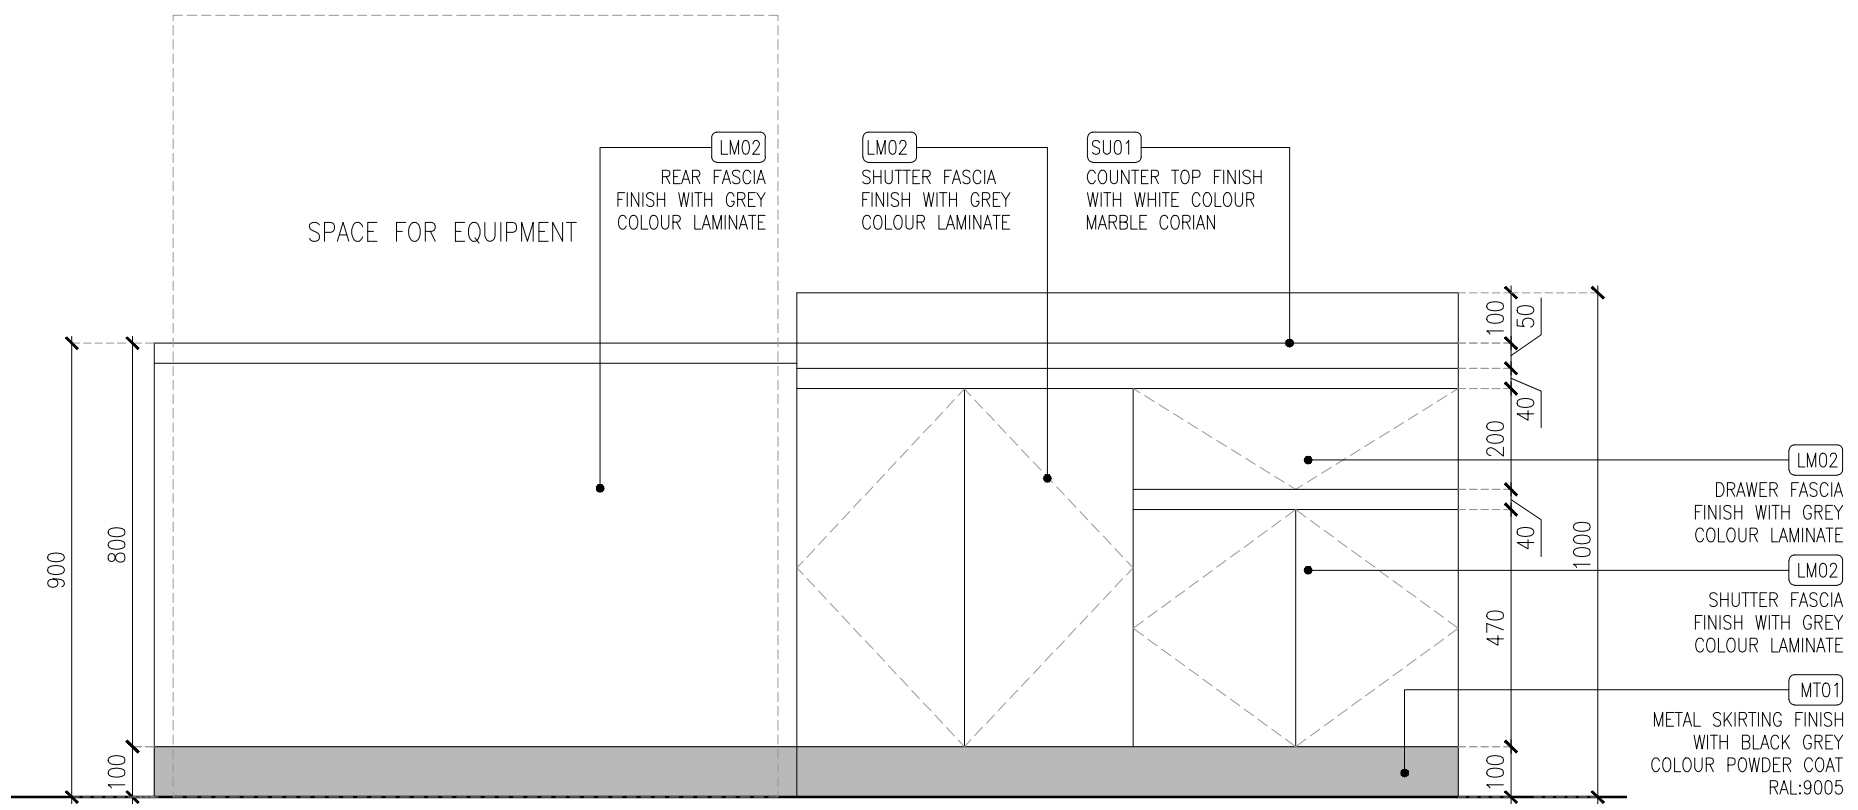


01 ELEVATION -03
04DE-402 1:15

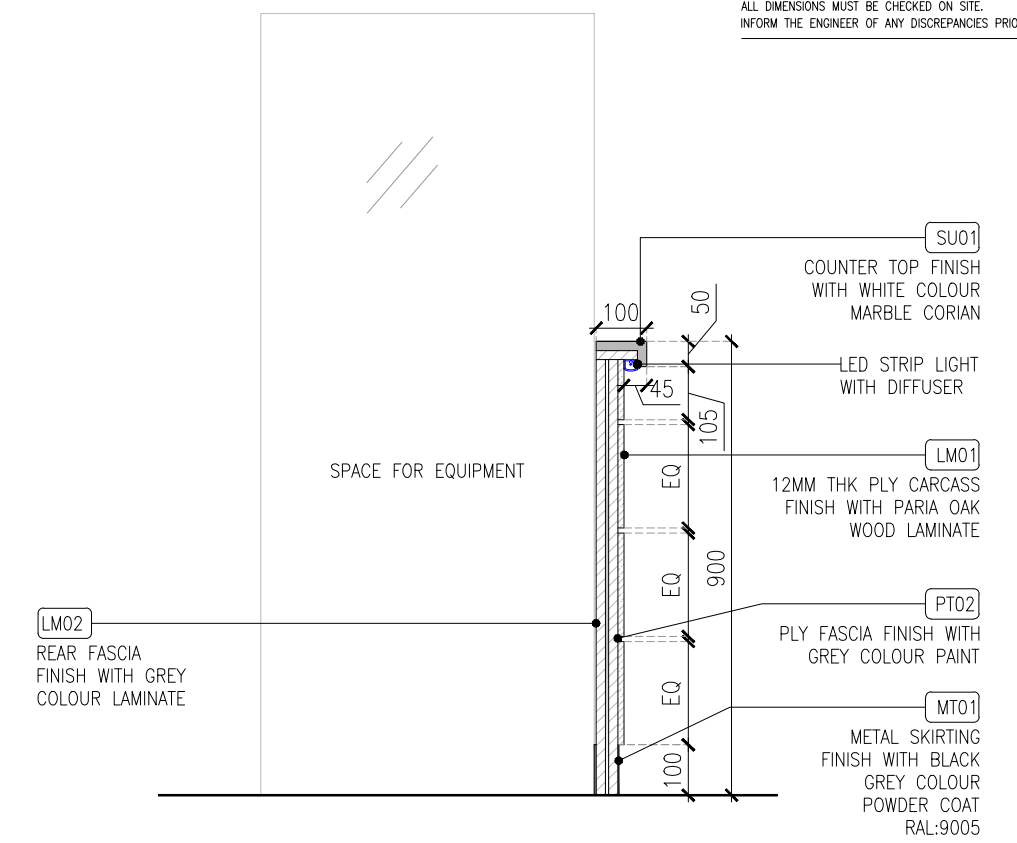

03 SECTION -01
04DE-402 1:15

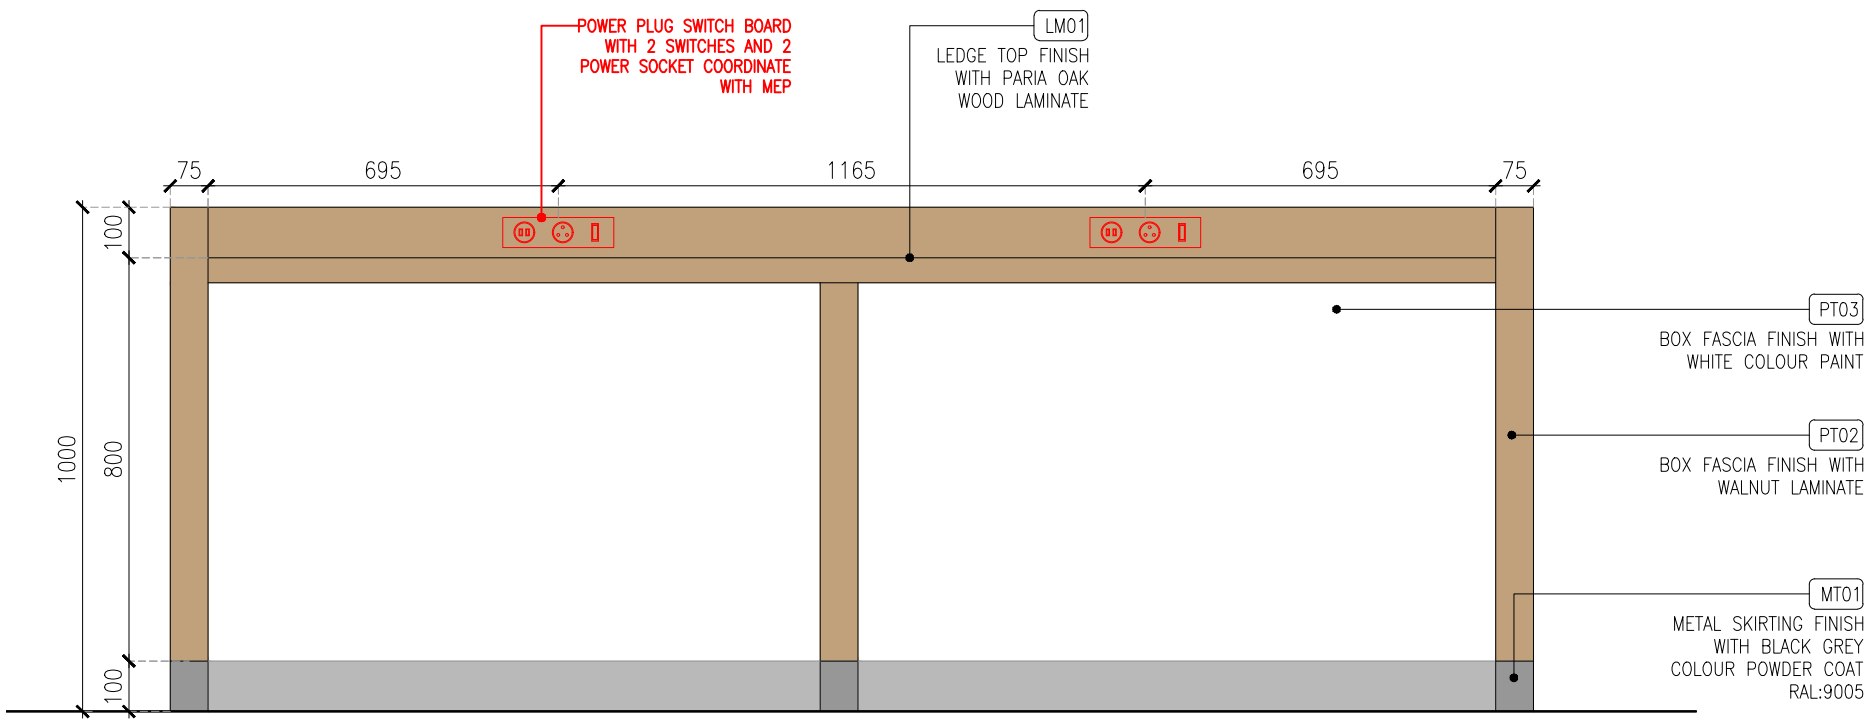

02 ELEVATION -04
04DE-402 1:15

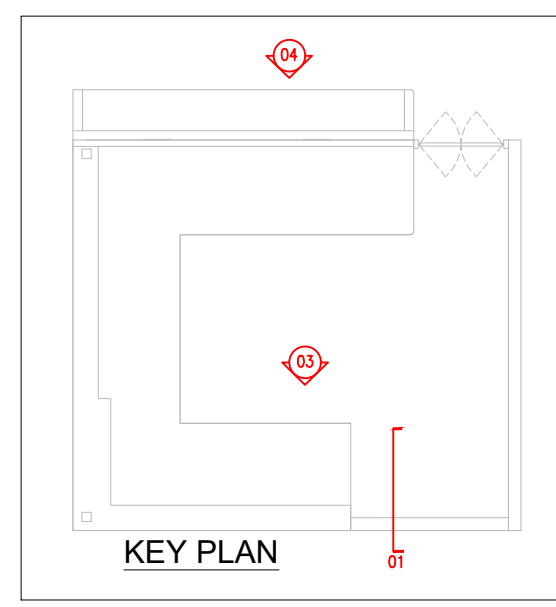

REV	DATE	DESCRIPTION	HOD	NM	DRN	CHK
T01	02.02.24	TENDER				




PROJECT
HATTI KAAPI FF52
GMR INTERNATIONAL
AIRPORT LIMITED,
HYDERABAD

DRAWING TITLE
J01&J02 -FRONT COUNTER &
LEDGE DETAIL PART-C


SCALE 1:15 DATE 02.02.2024 DRAWN HOD A3 SHEET

STATUS
TENDER


ORG	PROJECT NO	DRAWING TYPE	NUMBER	REV
TFS	XXXX 04DE	402	T01	

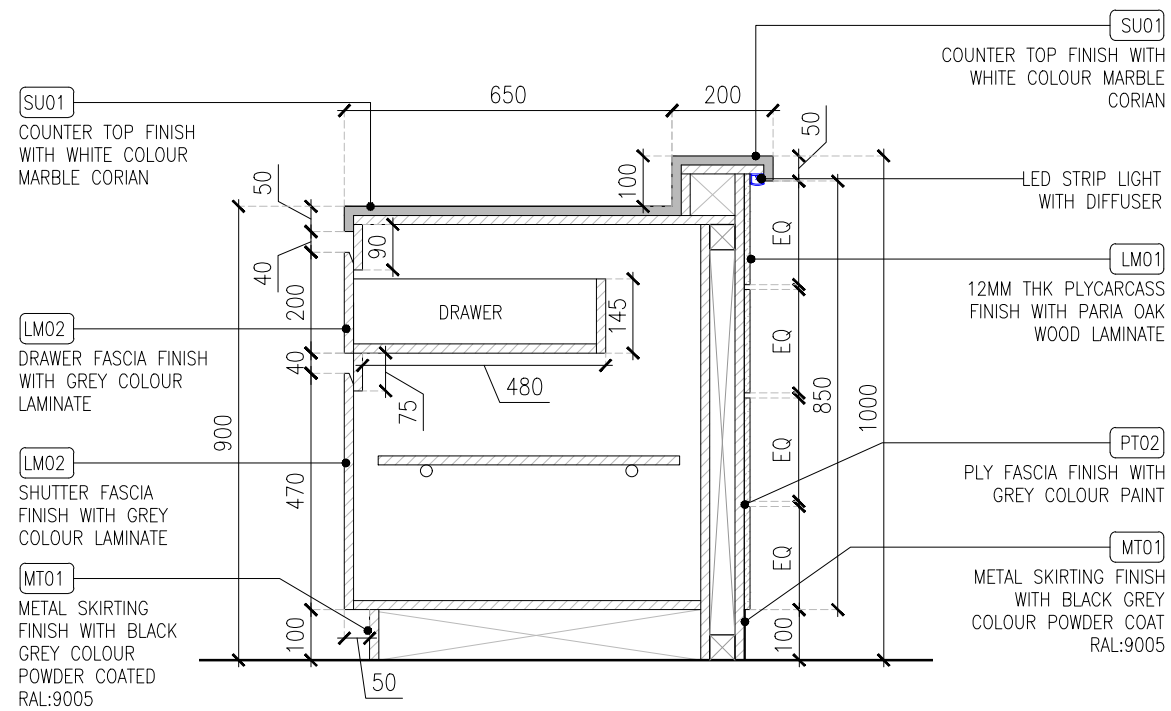


01 SECTION -02
04DE-403 1:15

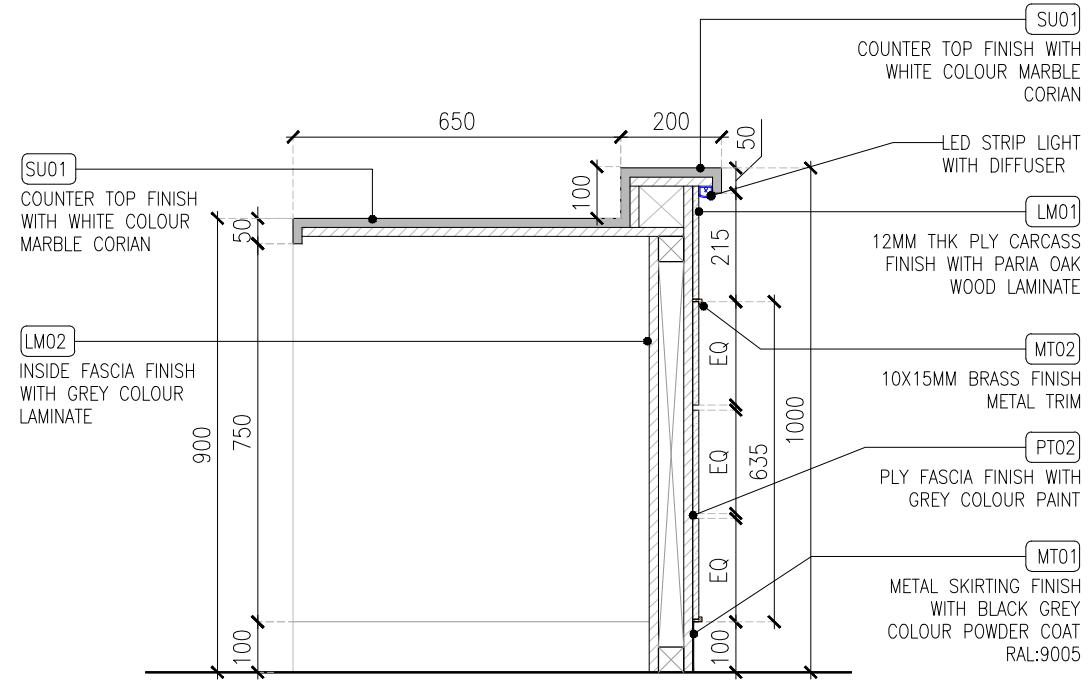


02 SECTION -03
04DE-403 1:15

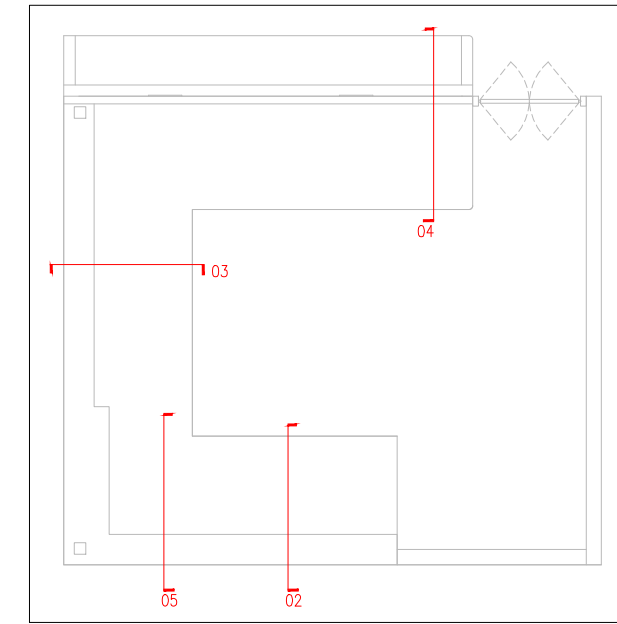

KEY PLAN

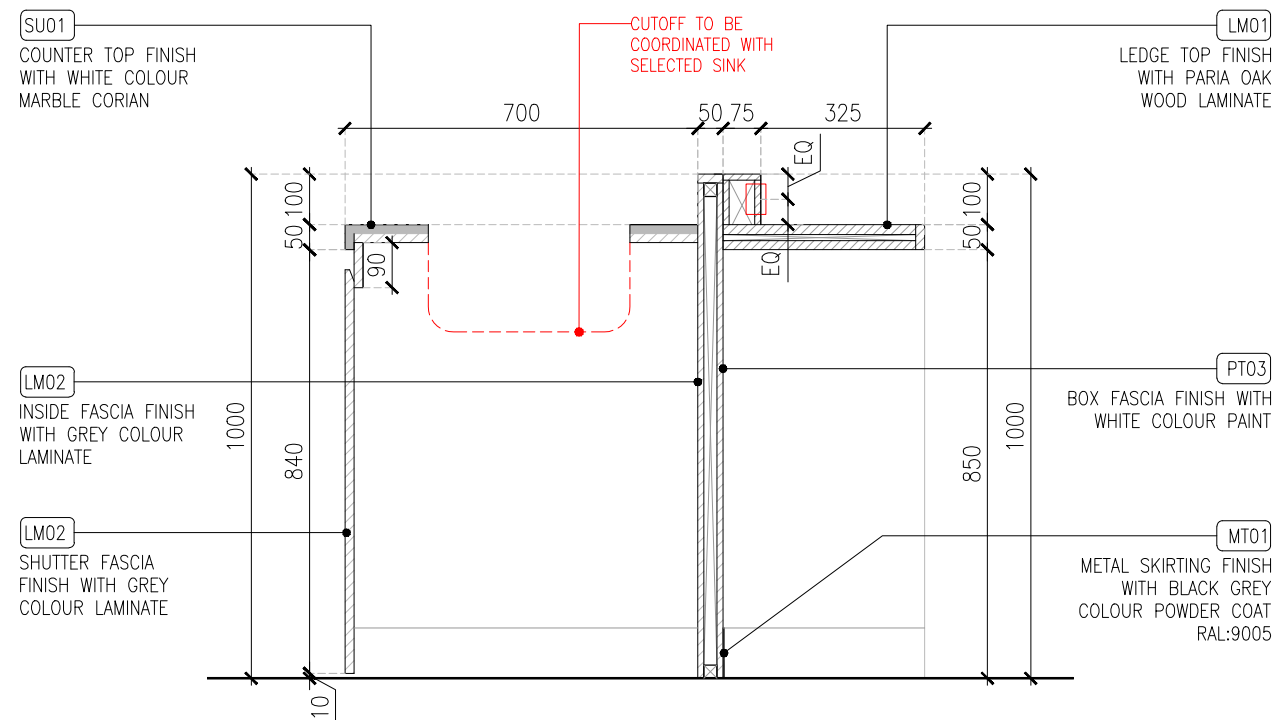

03 SECTION -04
04DE-403 1:15

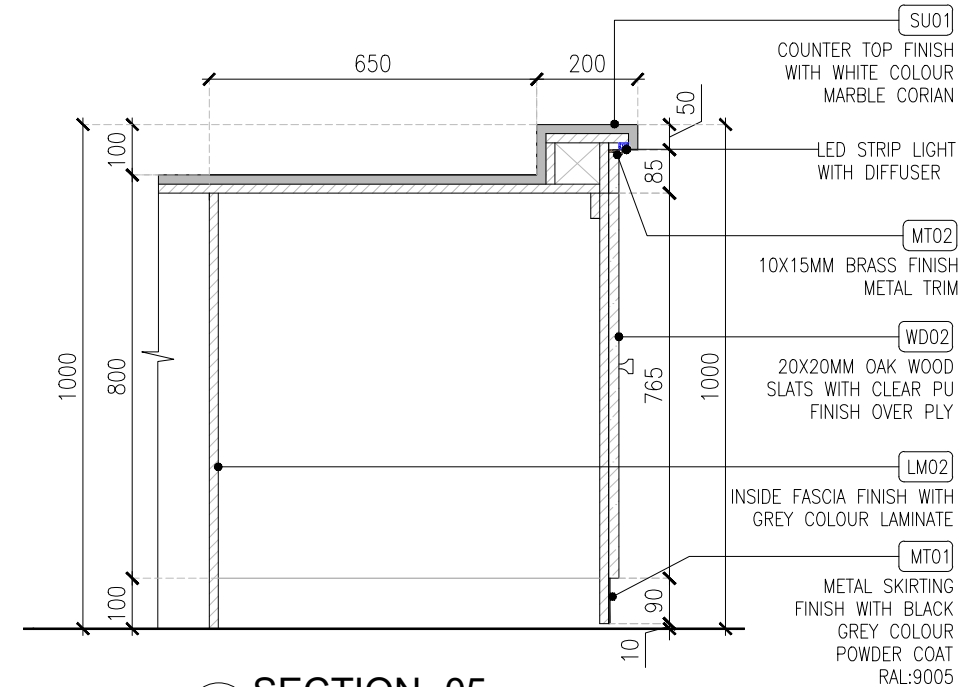

04 SECTION -05
04DE-403 1:15

T01	02.02.24	TENDER	HOD	NM
REV	DATE	DESCRIPTION	DRN	CHK



PROJECT
HATTI KAAPI FF52
GMR INTERNATIONAL
AIRPORT LIMITED,
HYDERABAD

DRAWING TITLE
J01&J02 -FRONT COUNTER &
LEDGE DETAIL PART-D


SCALE	DATE	DRAWN	HOD	A3 SHEET
1:15	02.02.2024			

STATUS


TENDER

ORG	PROJECT NO	DRAWING TYPE	NUMBER	REV
TFS	XXXX	04DE	403	T01


STRUCTURAL DETAILS ARE INDICATIVE ONLY

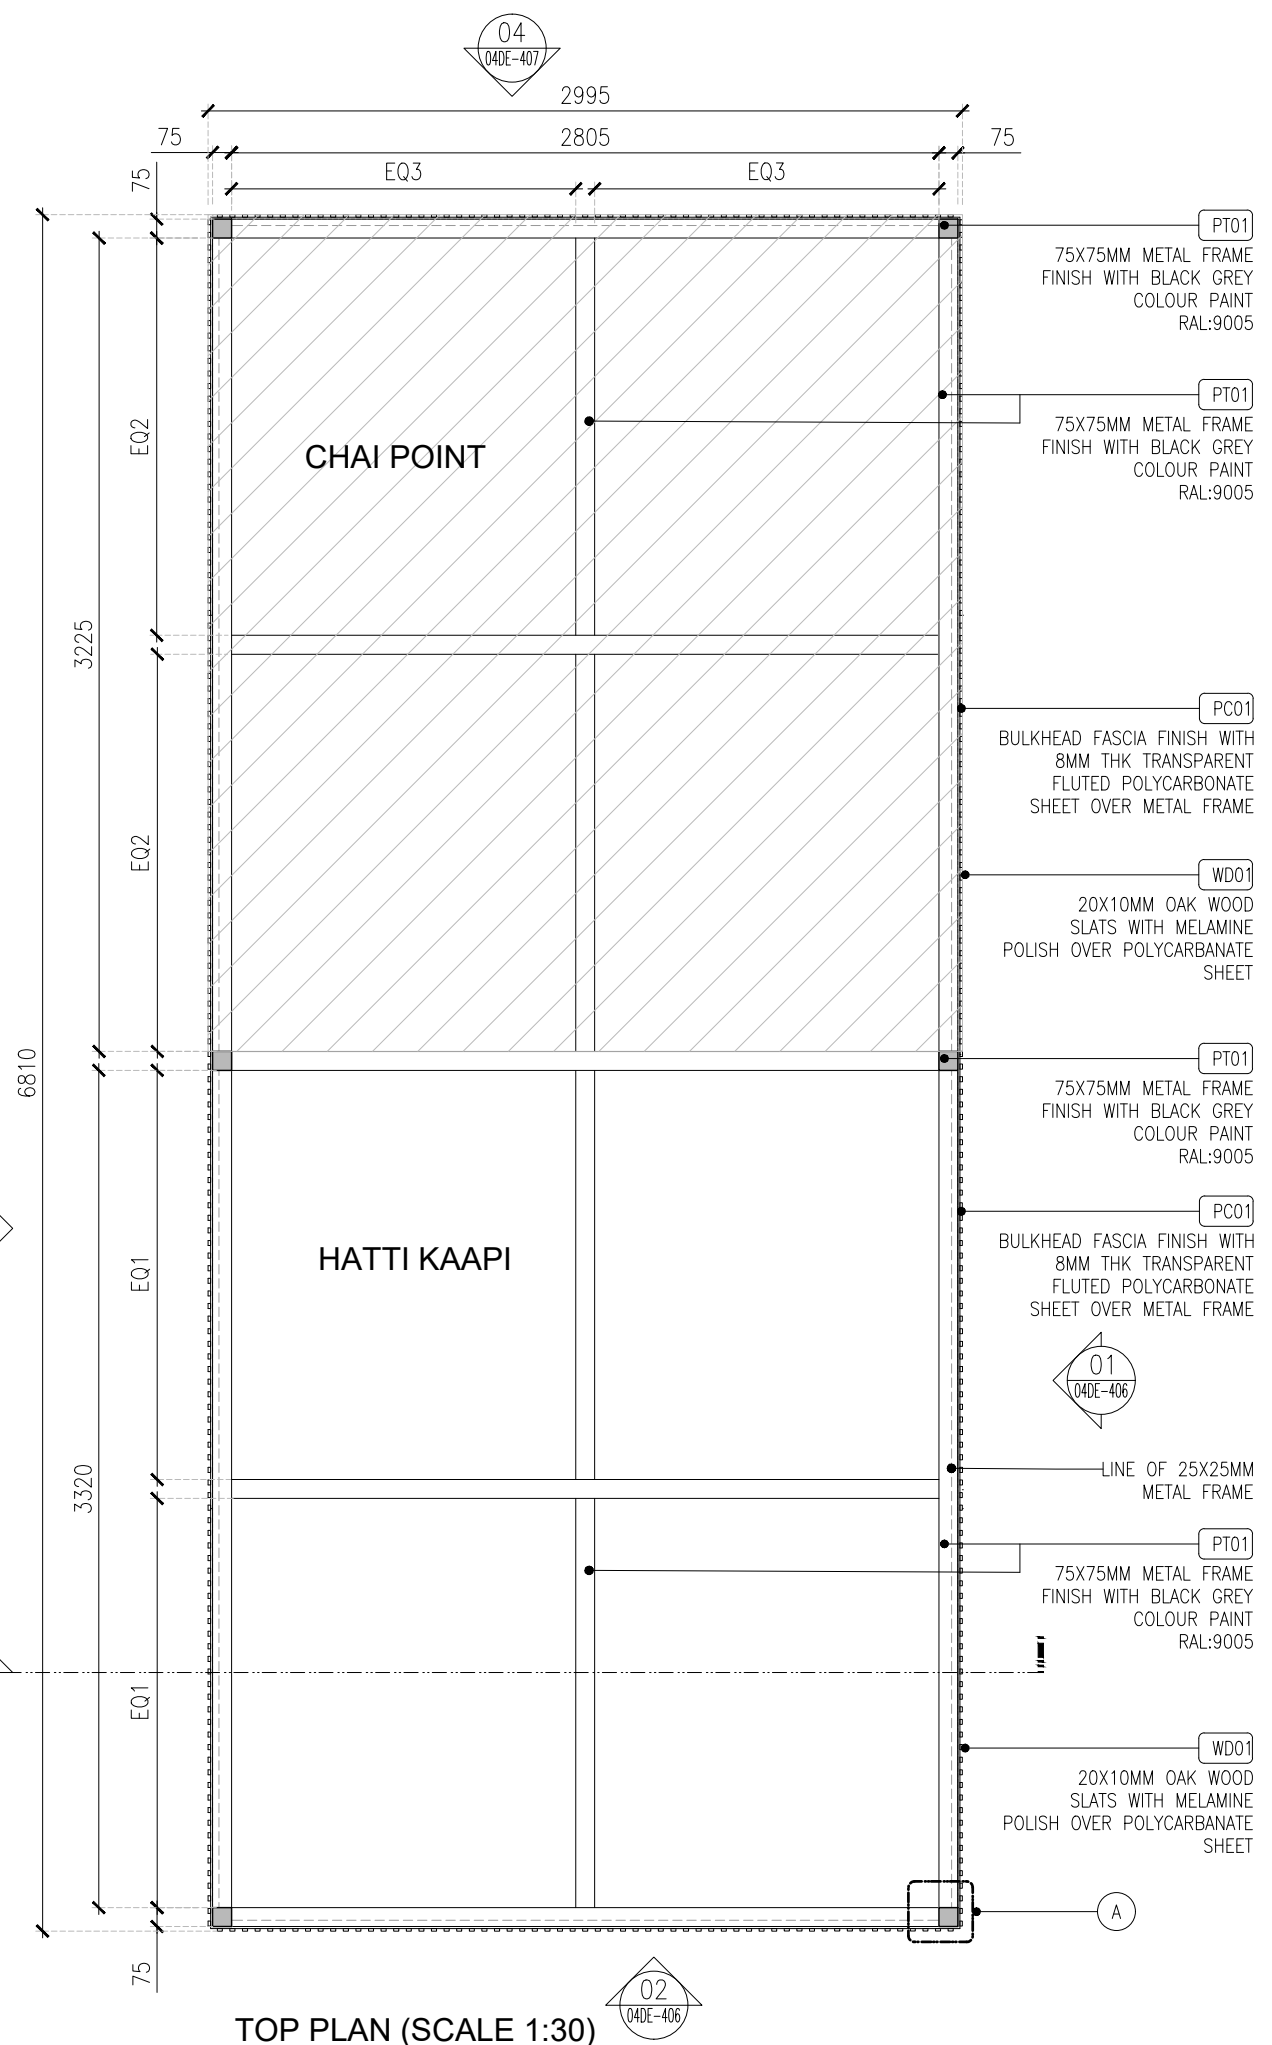


TOP PLAN (SCALE 1:30)

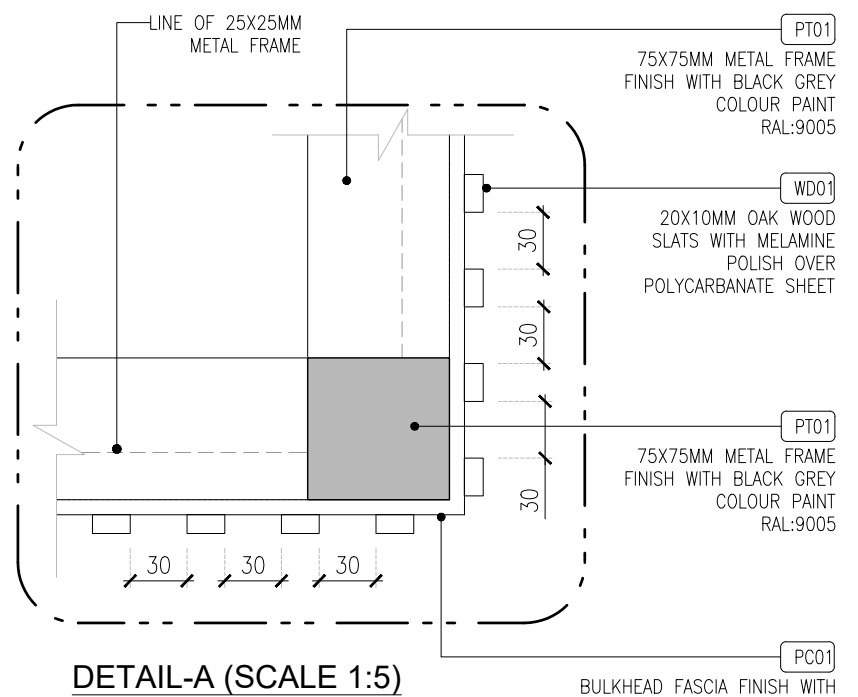

DETAIL-A (SCALE 1:5)

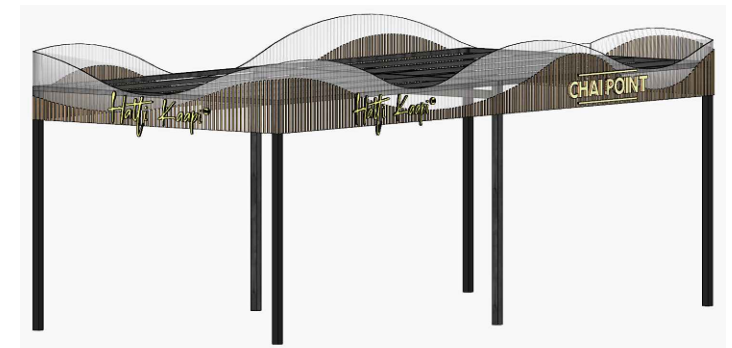

REF. IMAGE

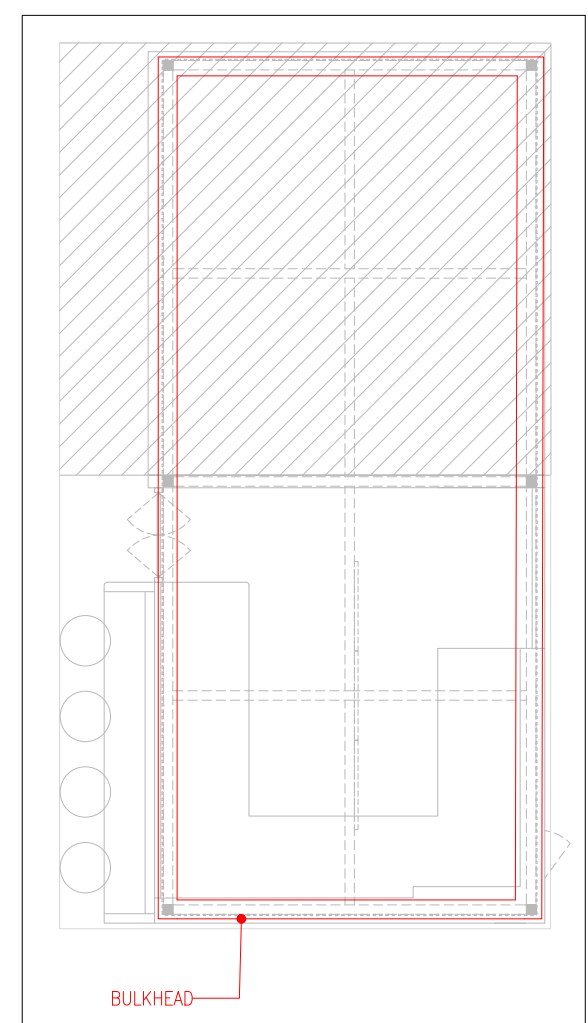

KEY PLAN

TO1	02.02.24	TENDER		HOD	NM
REV	DATE	DESCRIPTION		DRN	CHK



PROJECT
HATTI KAAPI FF52
GMR INTERNATIONAL
AIRPORT LIMITED,
HYDERABAD




DRAWING TITLE
J03-BULKHEAD DETAIL- PART:A

SCALE AS MENTIONED DATE 02.02.2024 DRAWN HOD A3 SHEET

STATUS
TENDER

ORG	PROJECT NO	DRAWING TYPE	NUMBER	REV
TFS	XXXX	04DE	404	T01

STRUCTURAL DETAILS ARE INDICATIVE ONLY

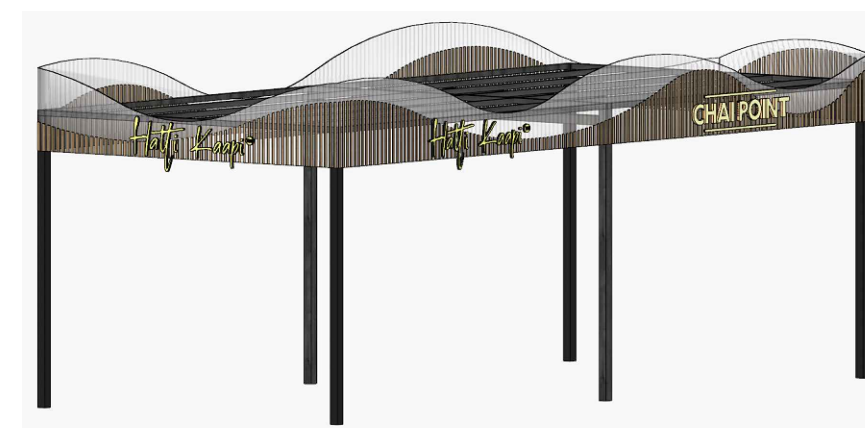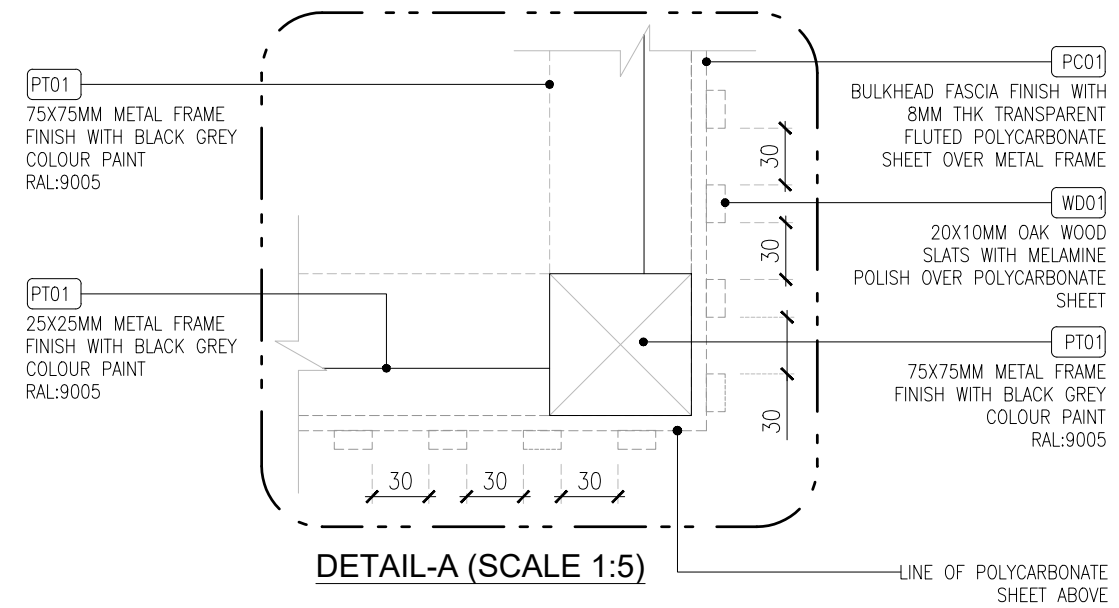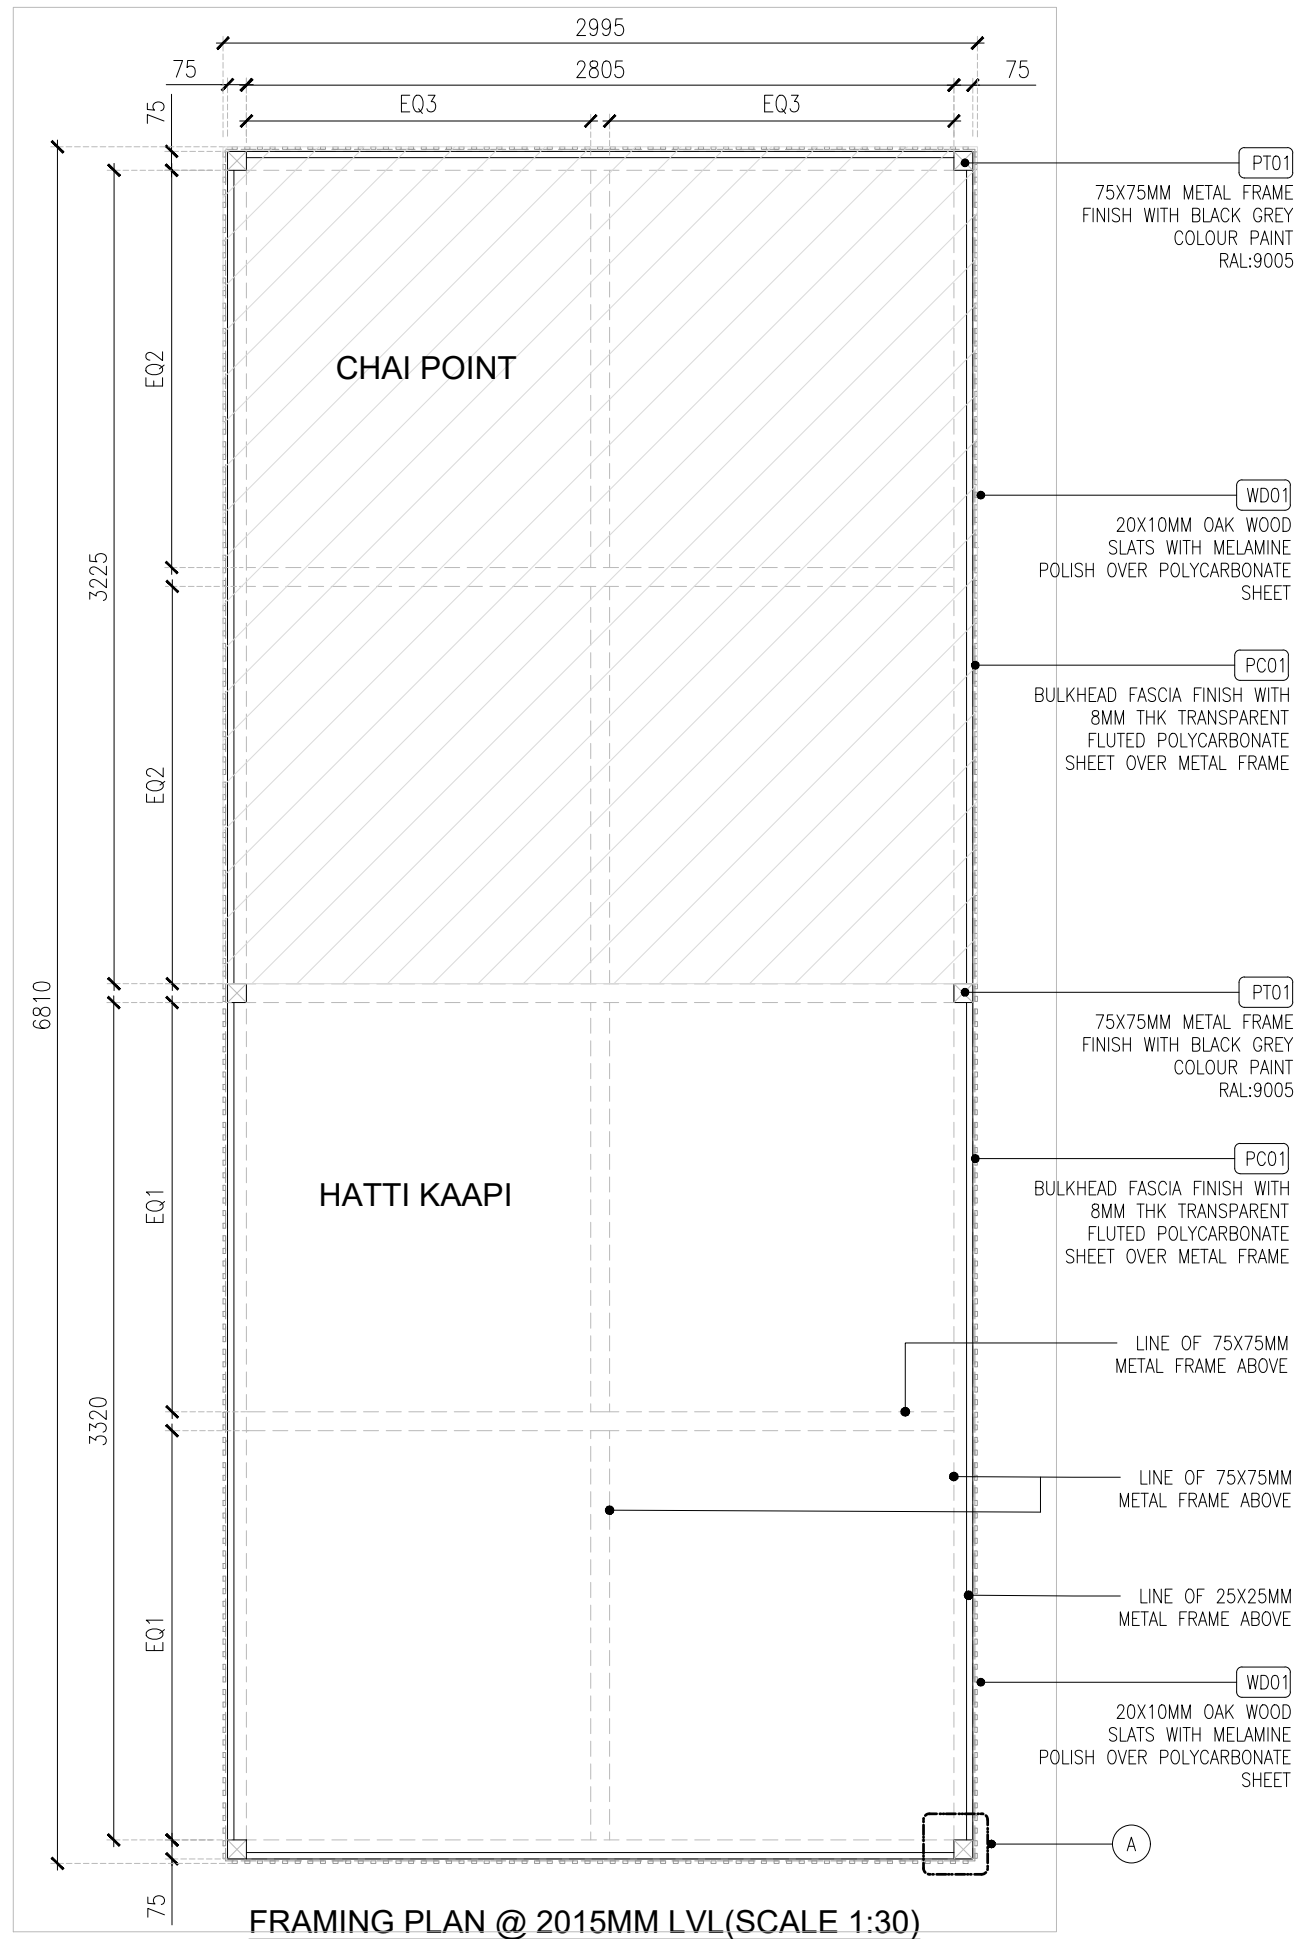

REV	DATE	DESCRIPTION	HOD	NM	DRN	CHK
T01	02.02.24	TENDER				



PROJECT
HATTI KAAPi FF52
GMR INTERNATIONAL
AIRPORT LIMITED,
HYDERABAD

DRAWING TITLE
J03-BULKHEAD DETAIL- PART:B

SCALE AS MENTIONED DATE: 02.02.2024 DRAWN HOD: A3 SHEET




STATUS
TENDER

ORG	PROJECT NO	DRAWING TYPE	NUMBER	REV
TFS	XXXX	04DE	405	T01

01 J03-BULKHEAD DETAIL - PART : B
04DE-405 1:30

ALL DIMENSIONS MUST BE CHECKED ON SITE.
INFORM THE ENGINEER OF ANY DISCREPANCIES PRIOR TO CONSTRUCTION.

STRUCTURAL DETAILS ARE INDICATIVE ONLY

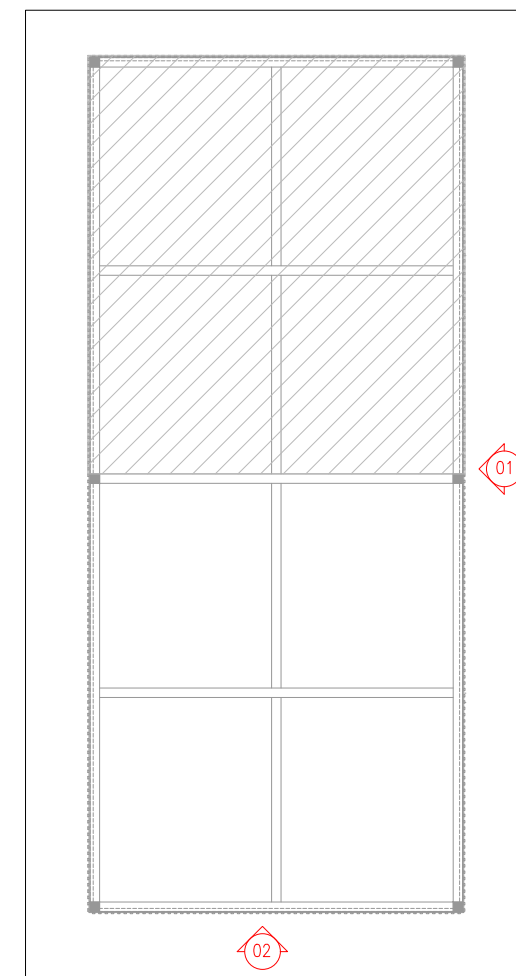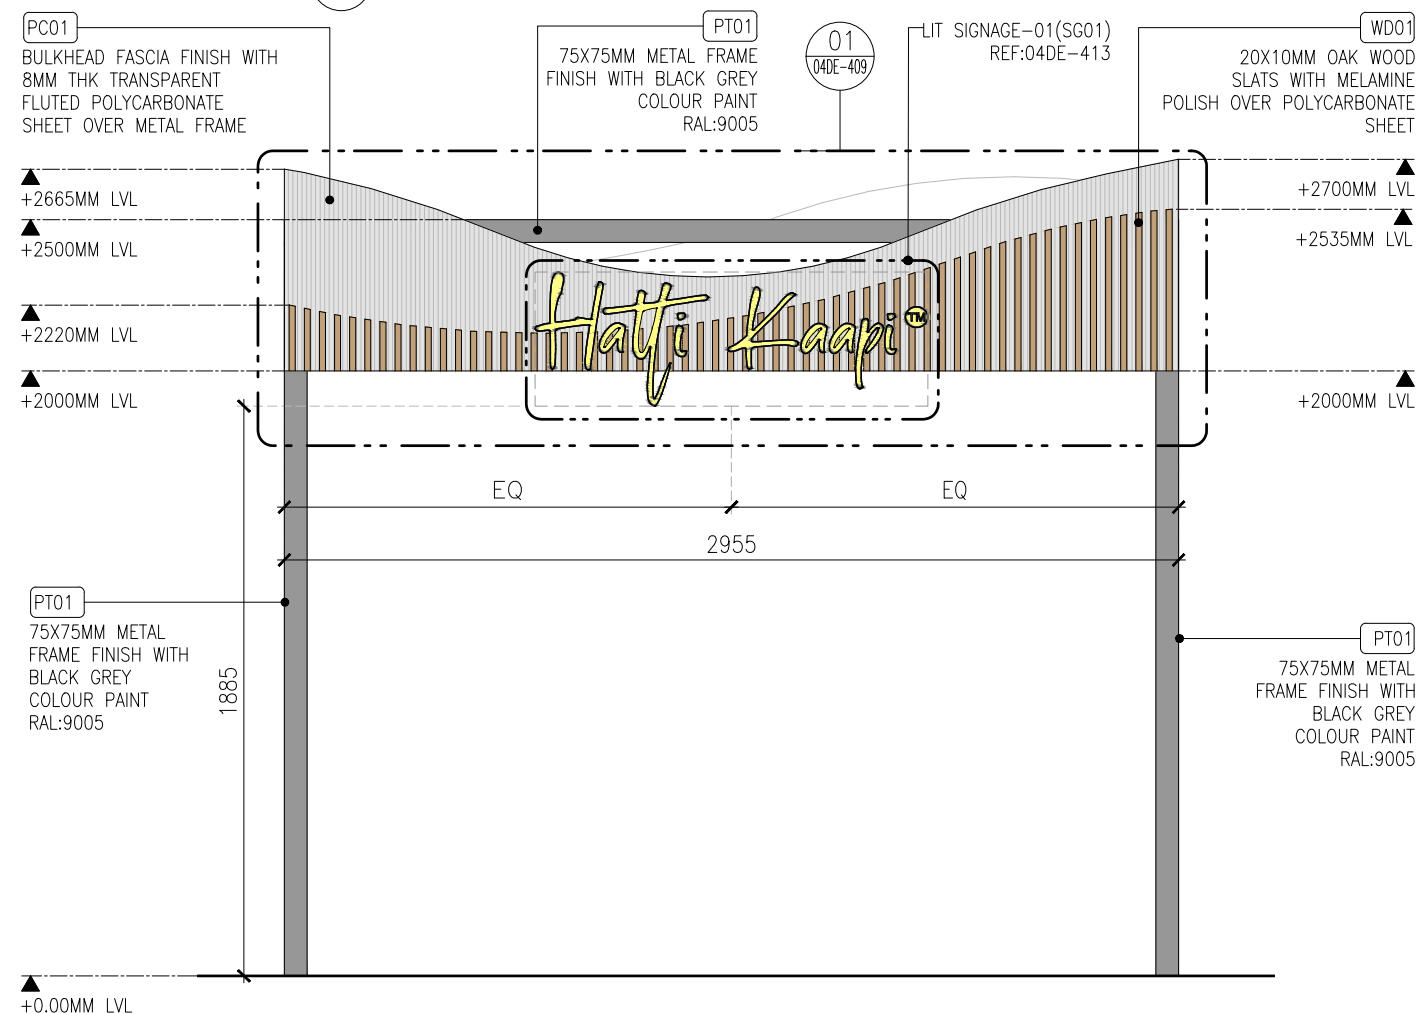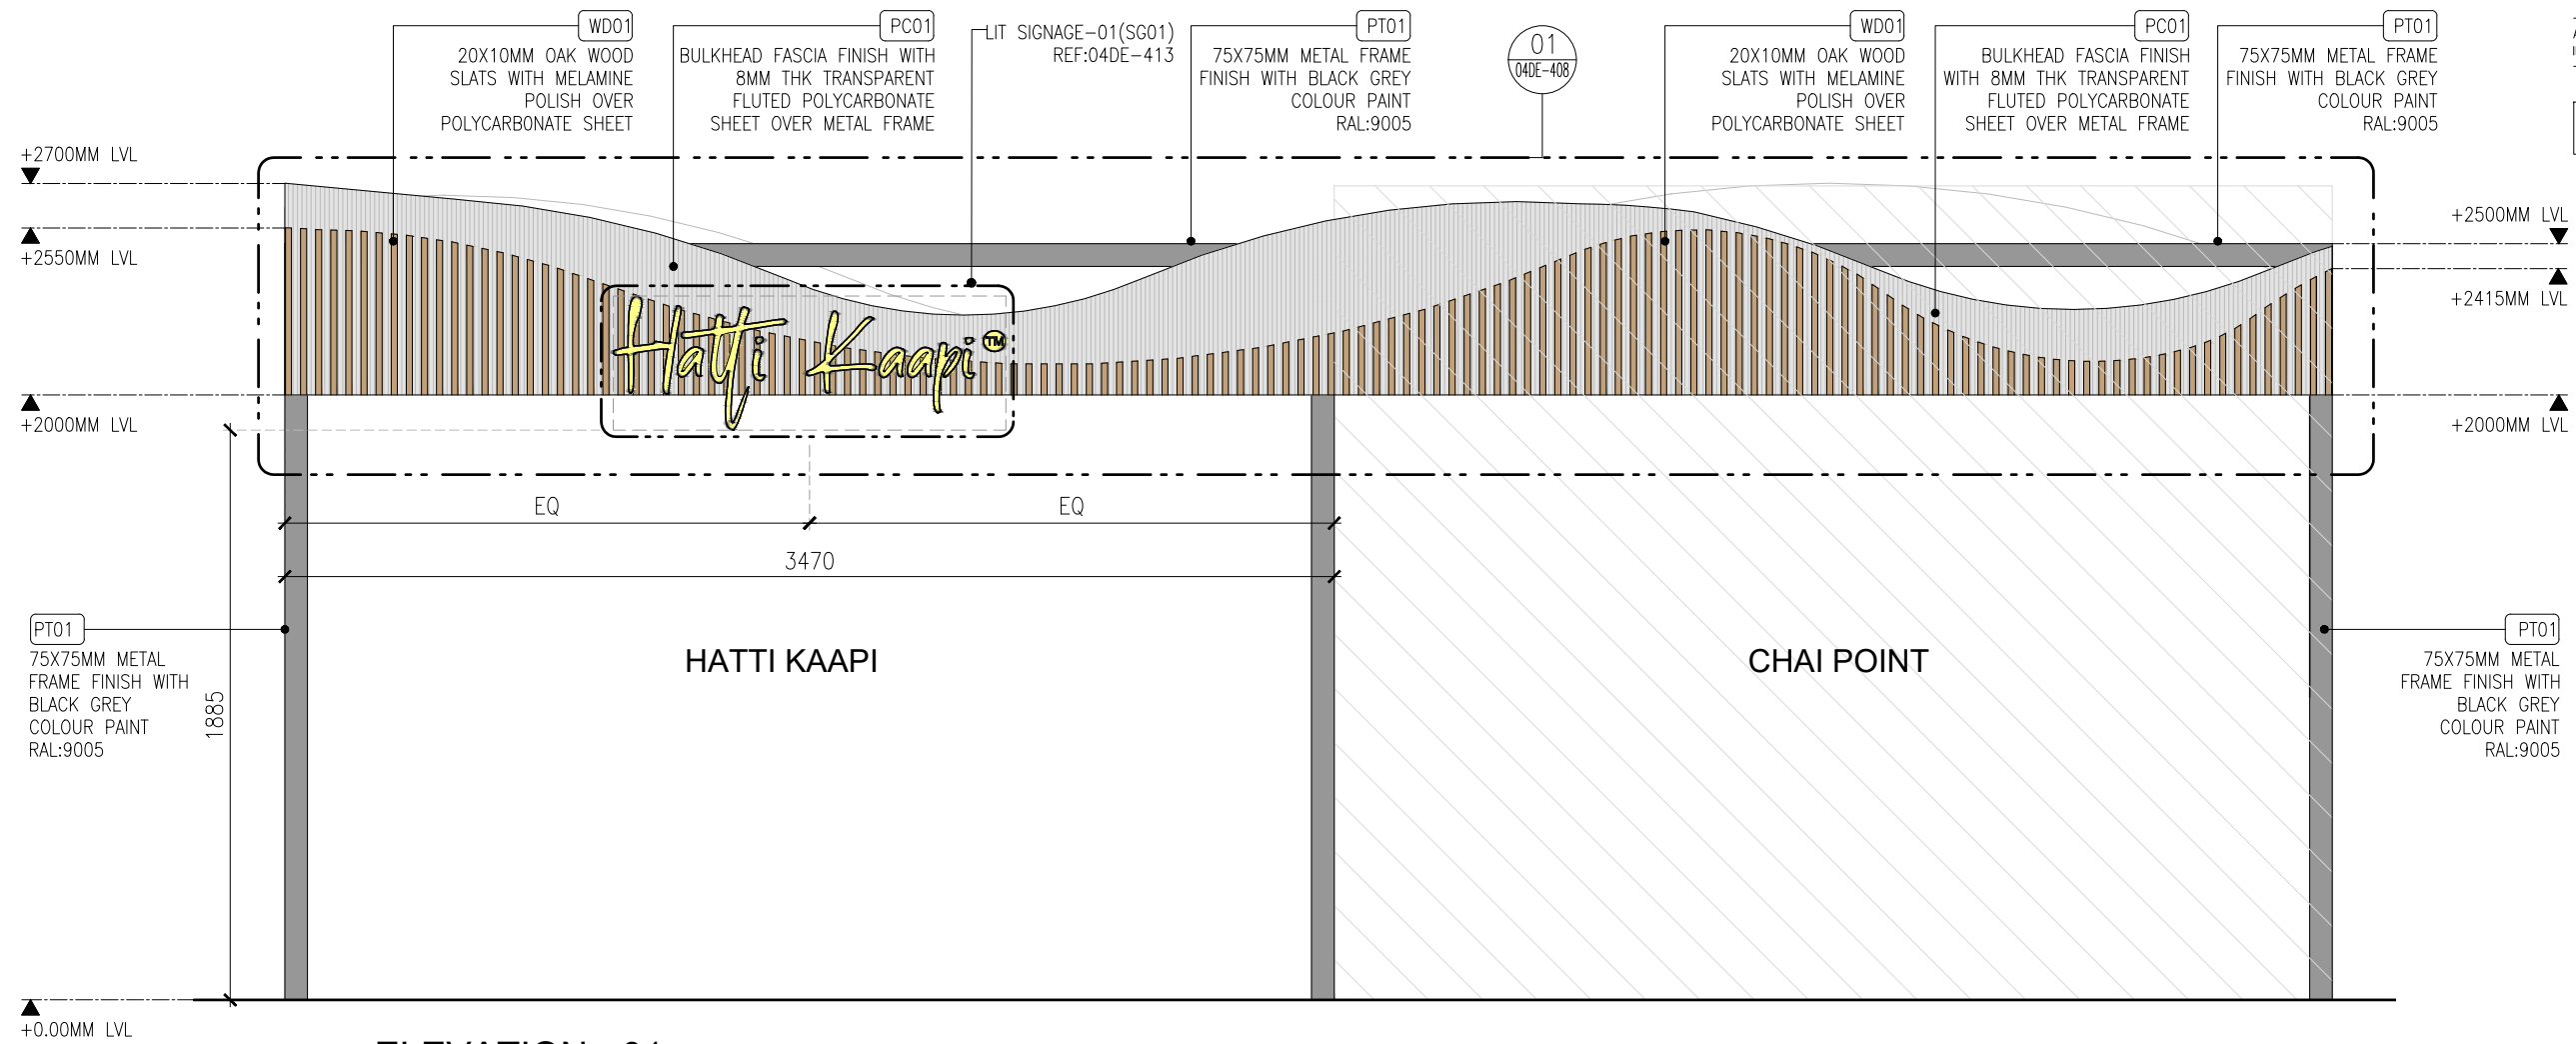

REV	DATE	DESCRIPTION	HOD	NR	CHK
T01	02.02.24	TENDER			



PROJECT
HATTI KAAPi FF52
GMR INTERNATIONAL
AIRPORT LIMITED,
HYDERABAD

DRAWING TITLE
J03-BULKHEAD DETAIL- PART:C




SCALE 1:25 DATE 02.02.2024 DRAWN HOD A3 SHEET

STATUS
TENDER

ORG PROJECT NO DRAWING TYPE NUMBER REV
TFS XXXX 04DE 406 T01

ALL DIMENSIONS MUST BE CHECKED ON SITE.
INFORM THE ENGINEER OF ANY DISCREPANCIES PRIOR TO CONSTRUCTION.

STRUCTURAL DETAILS ARE INDICATIVE ONLY

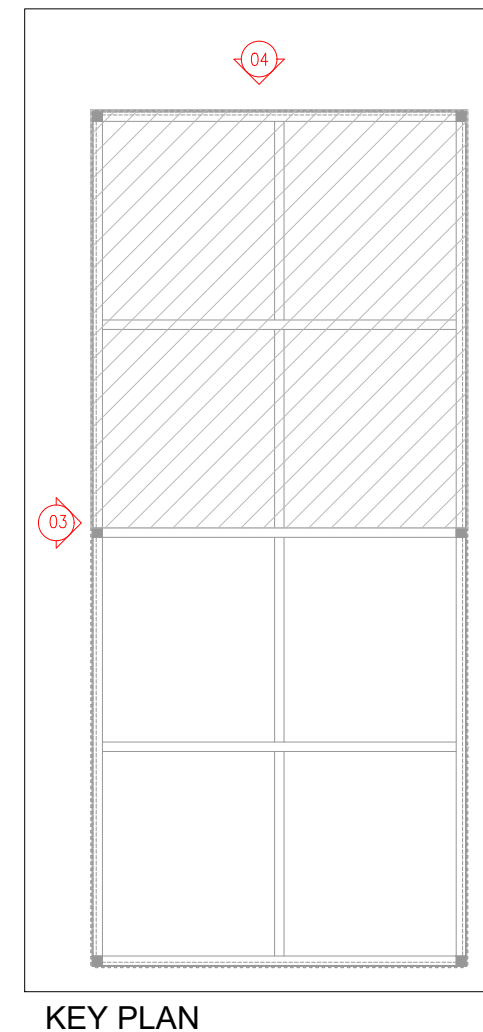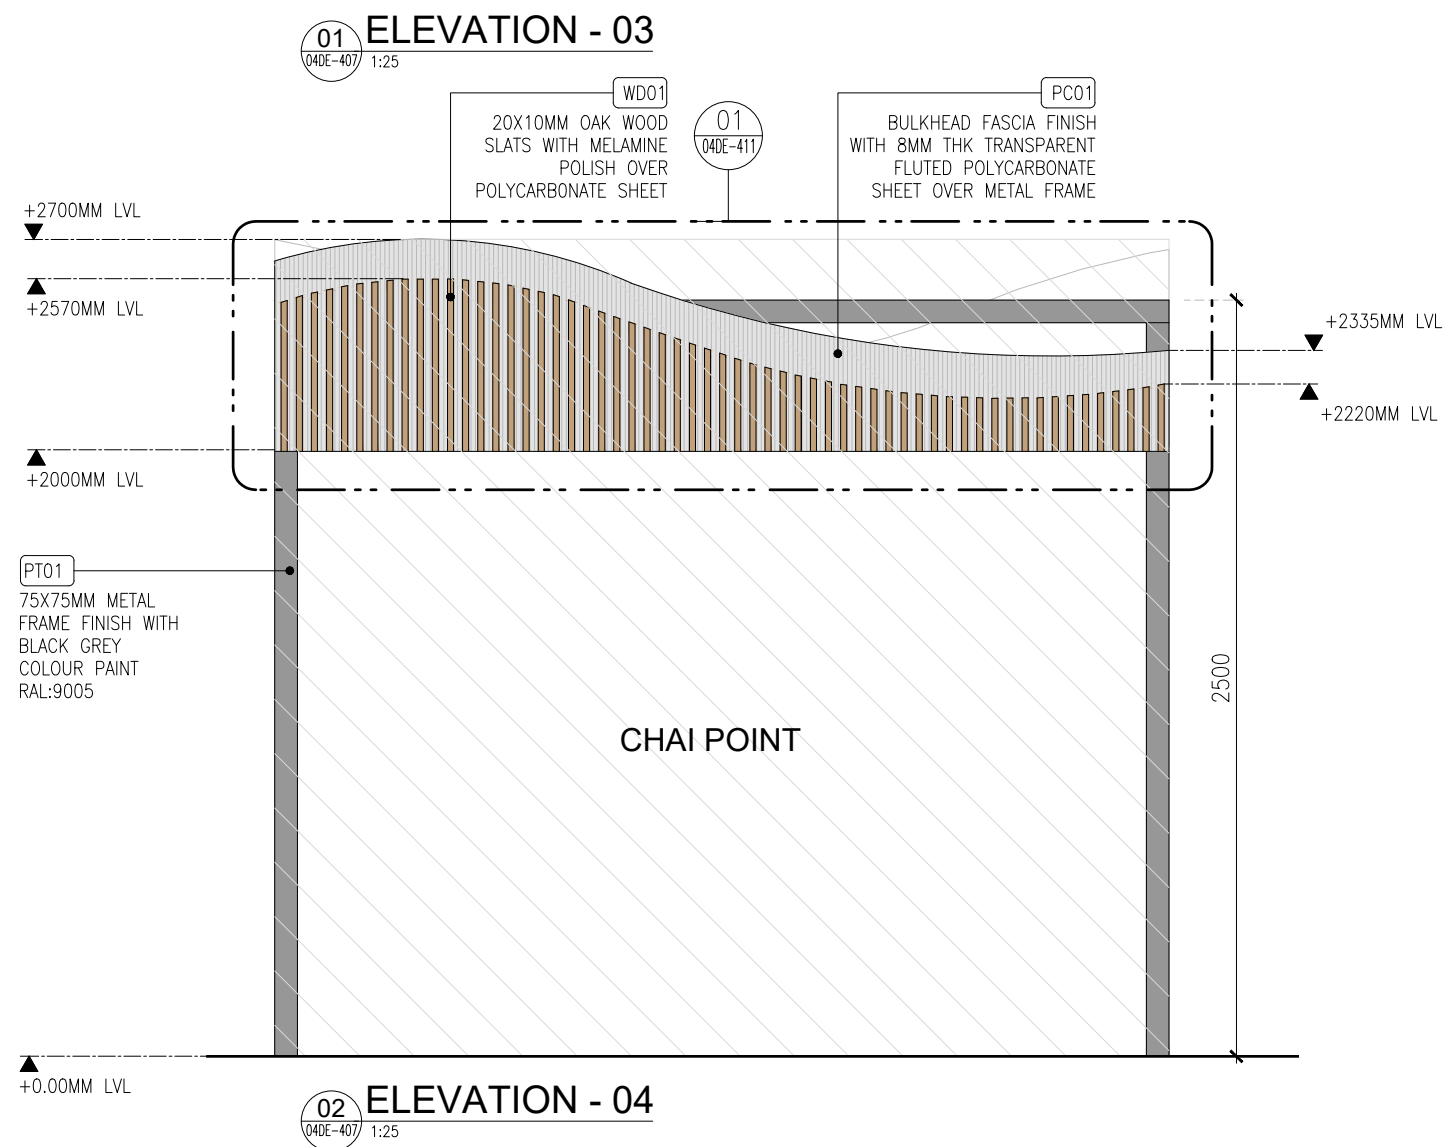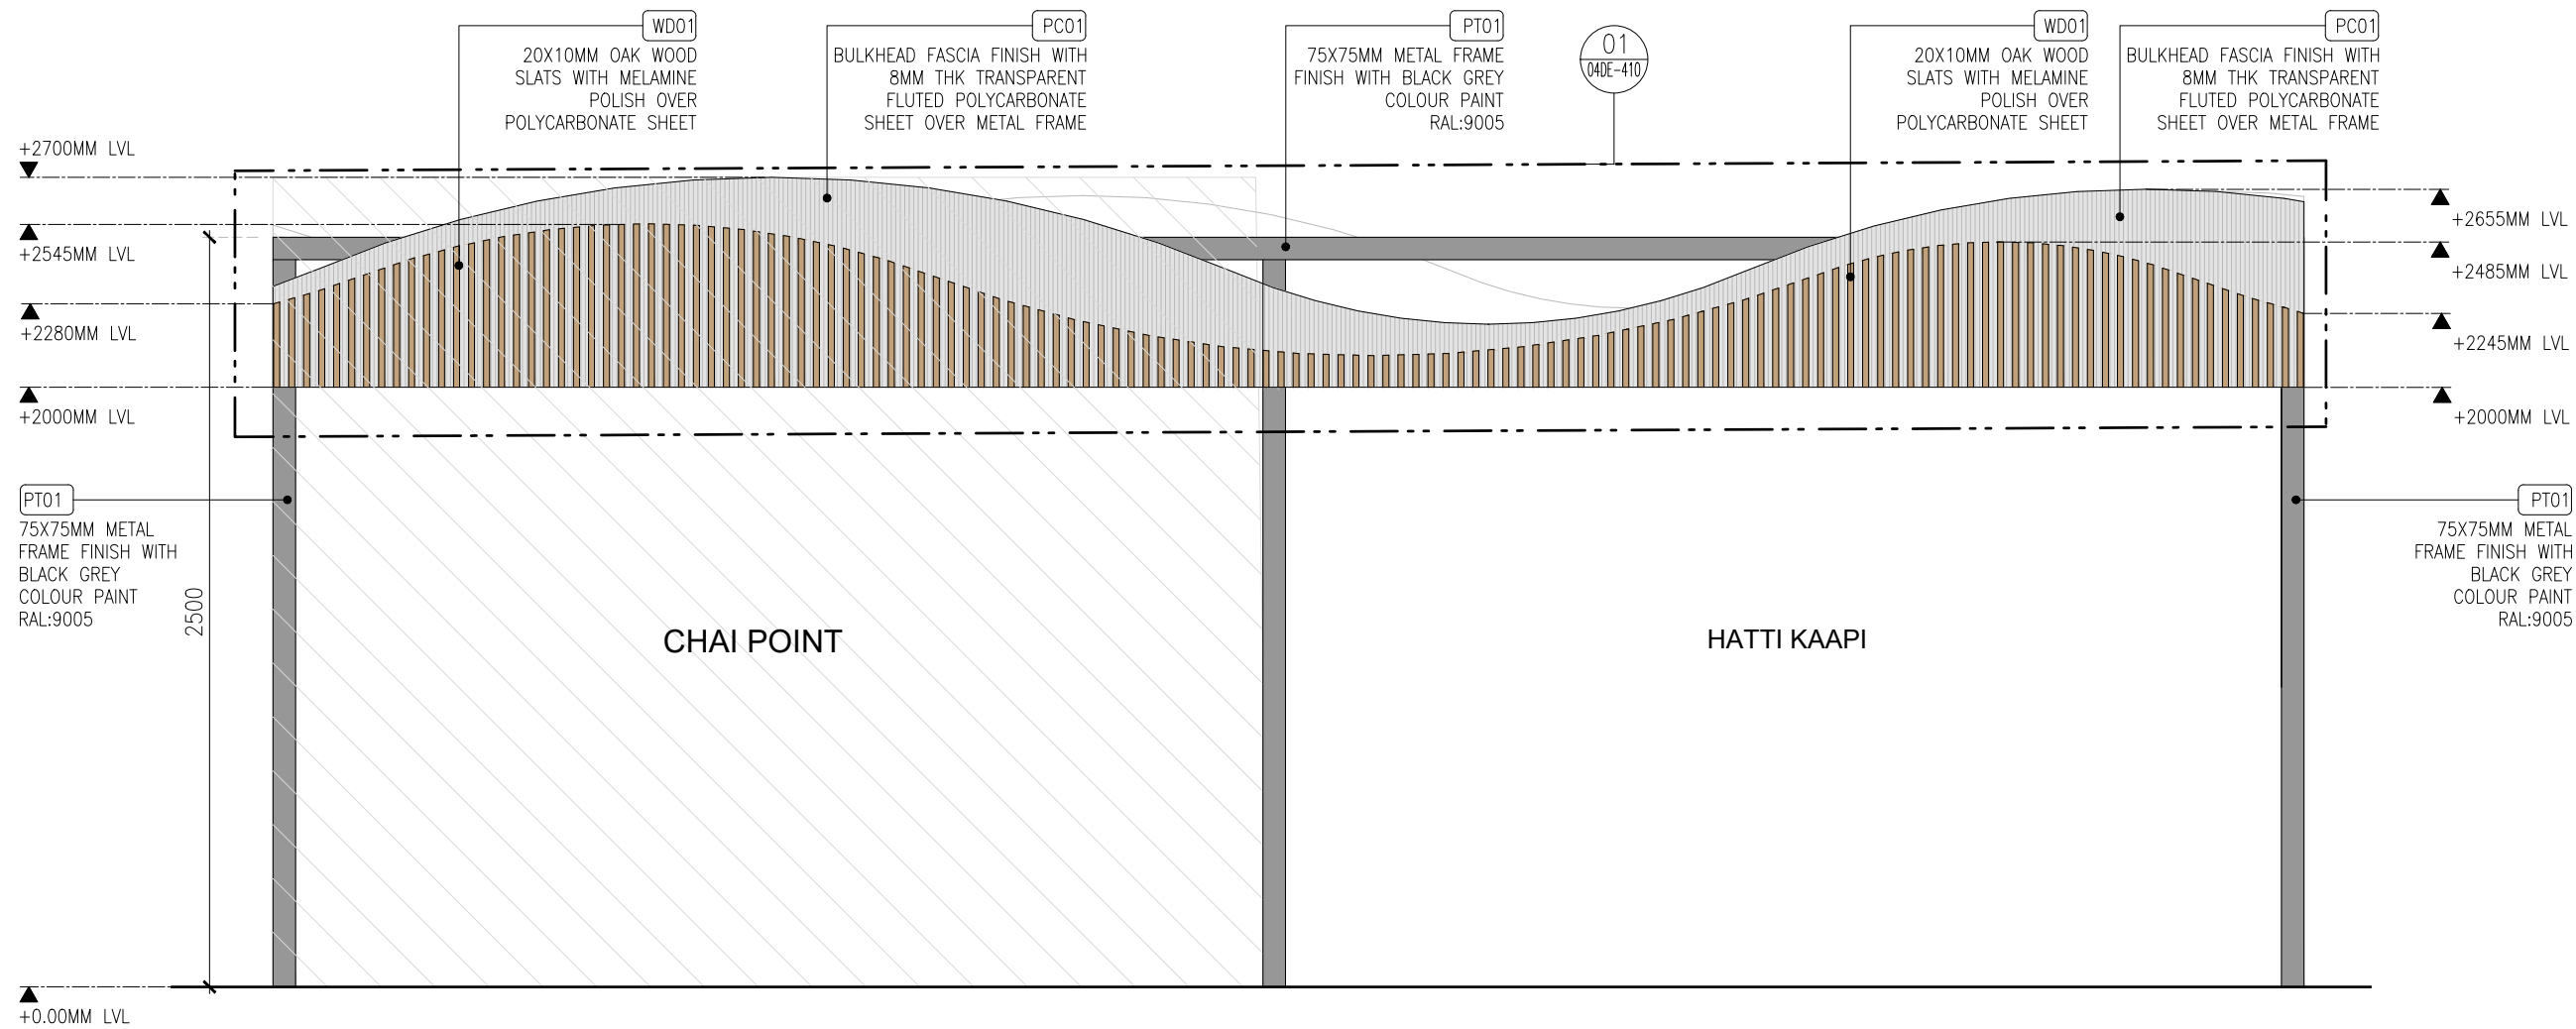

REV	DATE	DESCRIPTION	HOD	NM
T01	02.02.24	TENDER		




PROJECT
HATTI KAAPI FF52
GMR INTERNATIONAL
AIRPORT LIMITED,
HYDERABAD

DRAWING TITLE
J03-BULKHEAD DETAIL- PART:D


SCALE 1:25 DATE 02.02.2024 DRAWN HOD A3 SHEET

STATUS	ORG	PROJECT NO	DRAWING TYPE	NUMBER	REV
TENDER	TFS	XXXX	04DE	407	T01


STRUCTURAL DETAILS ARE INDICATIVE ONLY

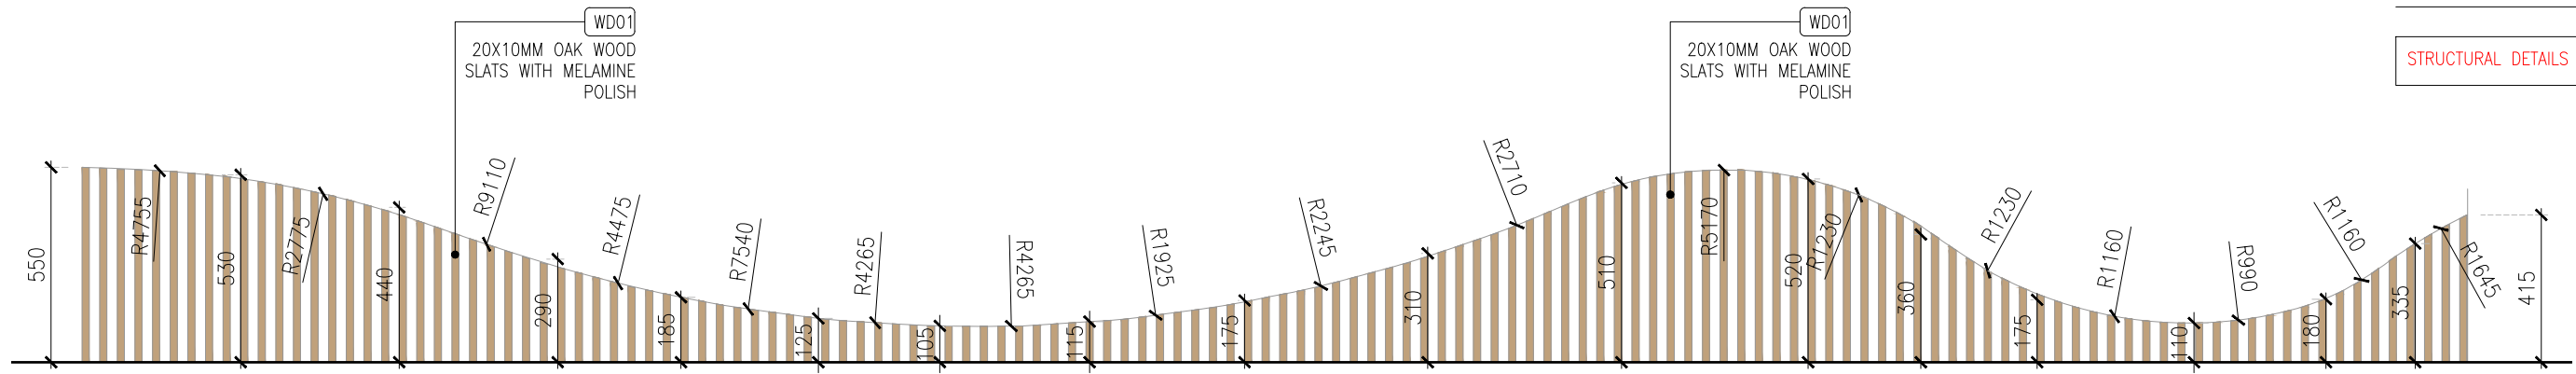


DETAIL-A(OAK WOOD SLATS)

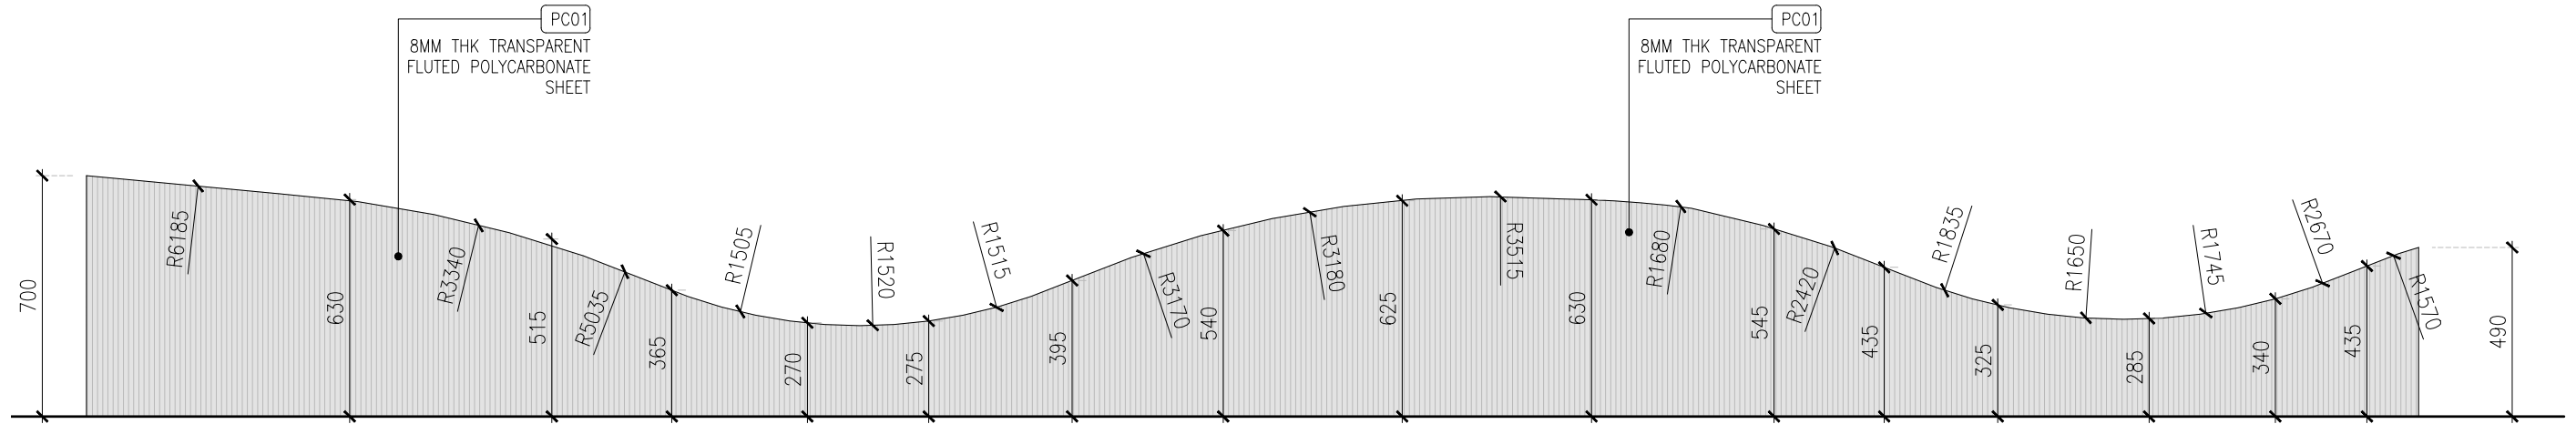

DETAIL-B(POLYCARBONATE SHEET)

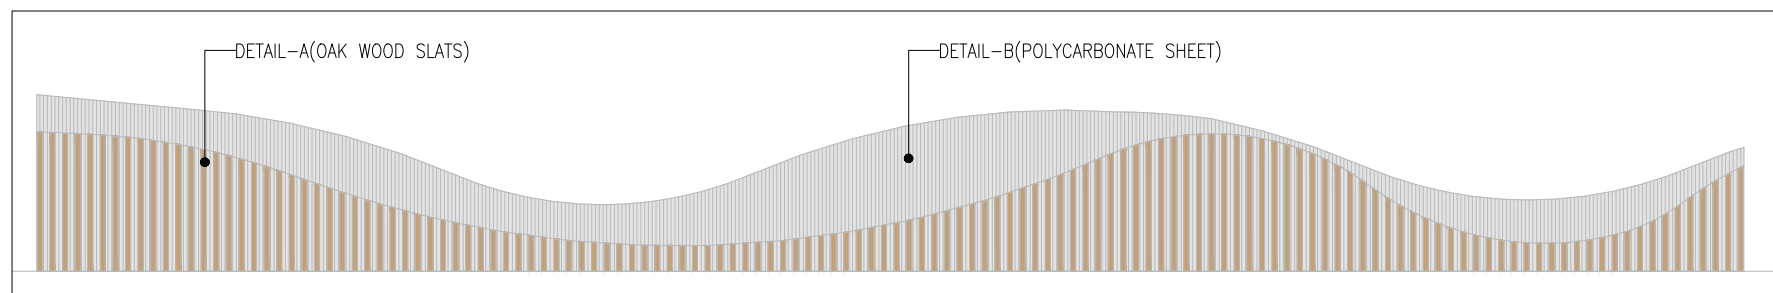

KEY PLAN(ELEVATION-01)

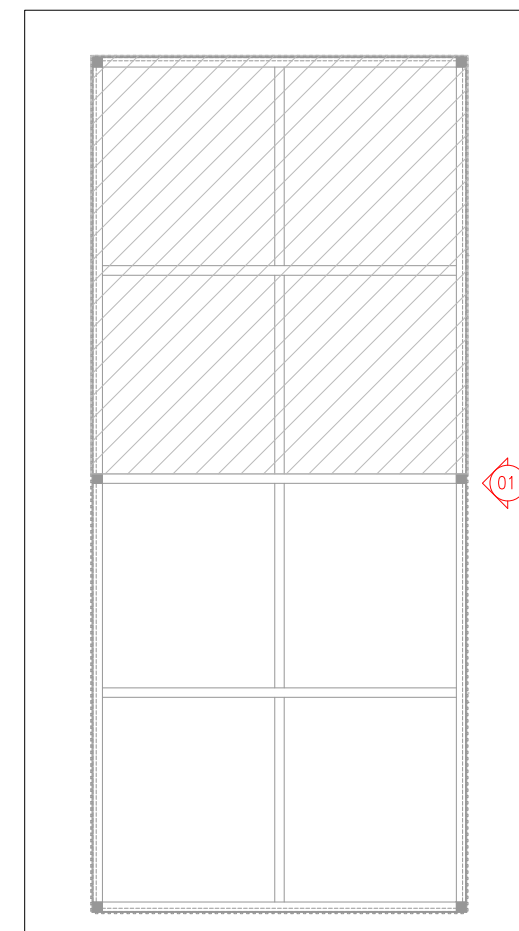

KEY PLAN

01 WOODEN SLATS & POLYCARBONATE SHEET DETAIL

04DE-408 1:20

REV	DATE	DESCRIPTION	TENDER	HOD	NM
TO1	02.02.24				



PROJECT
HATTI KAAPI FF52
GMR INTERNATIONAL
AIRPORT LIMITED,
HYDERABAD


DRAWING TITLE
J03-BULKHEAD DETAIL- PART:E

SCALE 1:20 DATE 02.02.2024 DRAWN HOD A3 SHEET


STATUS
TENDER

ORG	PROJECT NO	DRAWING TYPE	NUMBER	REV
TFS	XXXX	04DE	408	T01


STRUCTURAL DETAILS ARE INDICATIVE ONLY

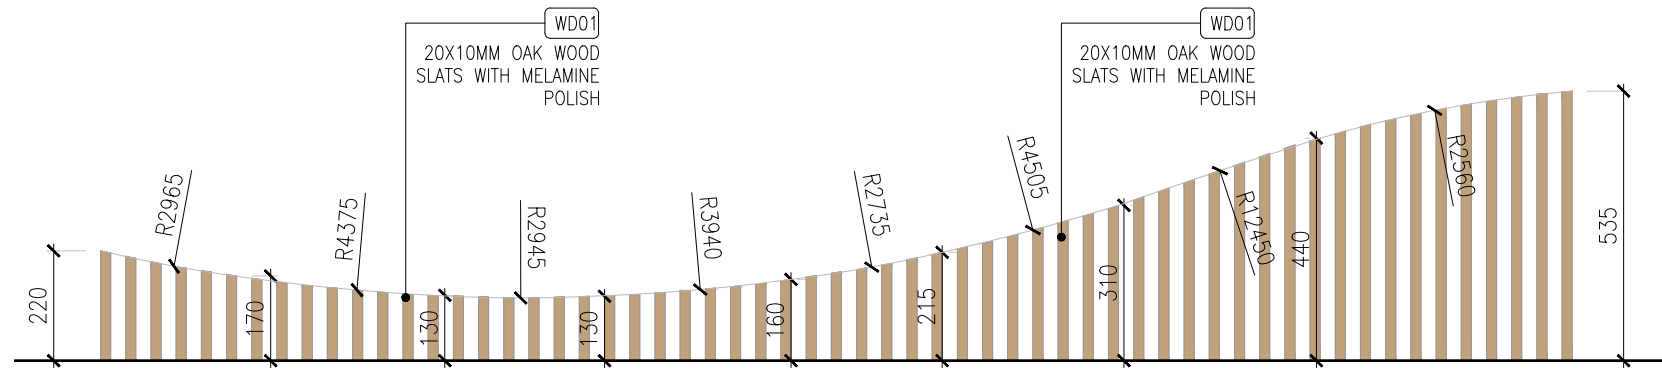

DETAIL-A(OAK WOOD SLATS)

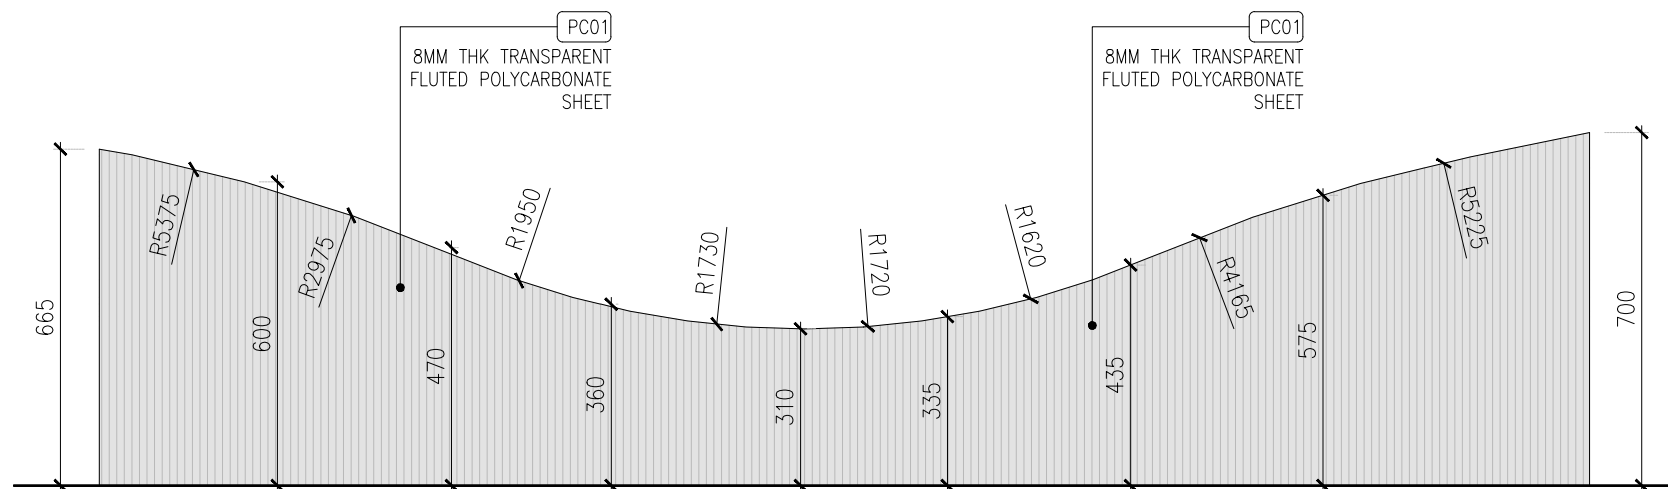


DETAIL-B(POLYCARBONATE SHEET)

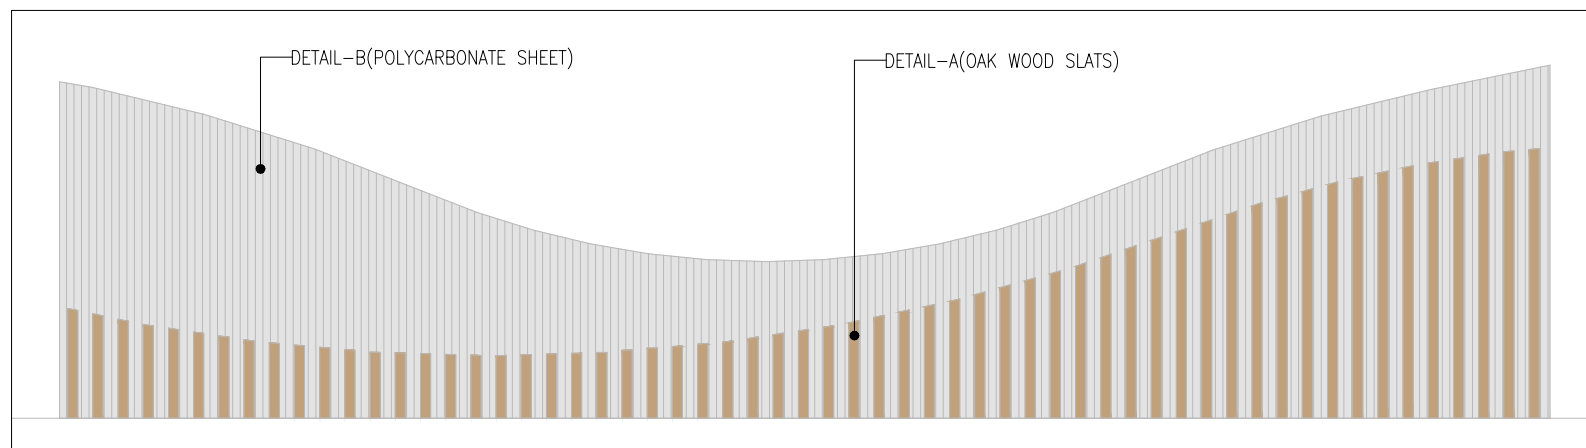

KEY PLAN(ELEVATION-02)

01 WOODEN SLATS & POLYCARBONATE SHEET DETAIL
04DE-409 1:15

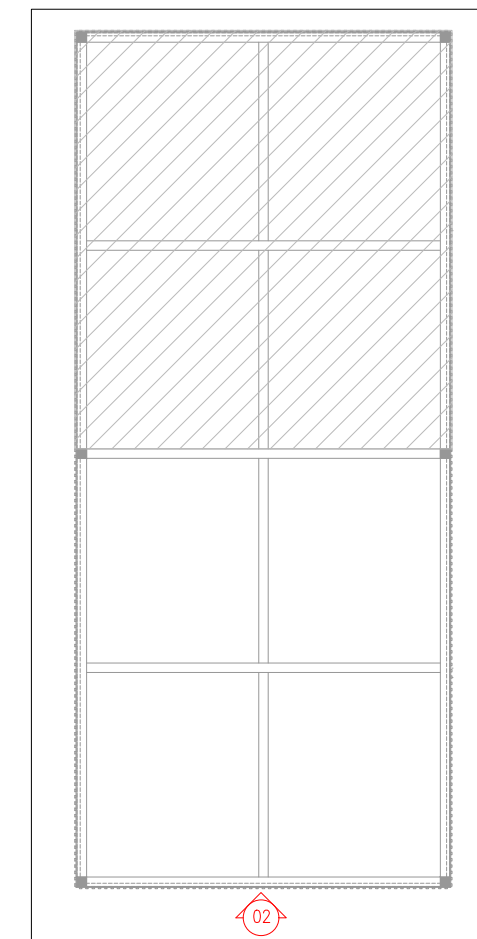

KEY PLAN

TO1	02.02.24	TENDER	HOD	NM
REV	DATE	DESCRIPTION	DRN	CHK



PROJECT
HATTI KAAPI FF52
GMR INTERNATIONAL
AIRPORT LIMITED,
HYDERABAD





DRAWING TITLE
J03-BULKHEAD DETAIL- PART:F

SCALE	1:15	DATE	02.02.2024	DRAWN	HOD	A3	SHEET
-------	------	------	------------	-------	-----	----	-------

STATUS
TENDER

ORG	PROJECT NO	DRAWING TYPE	NUMBER	REV
TFS	XXXX	04DE	409	T01

STRUCTURAL DETAILS ARE INDICATIVE ONLY

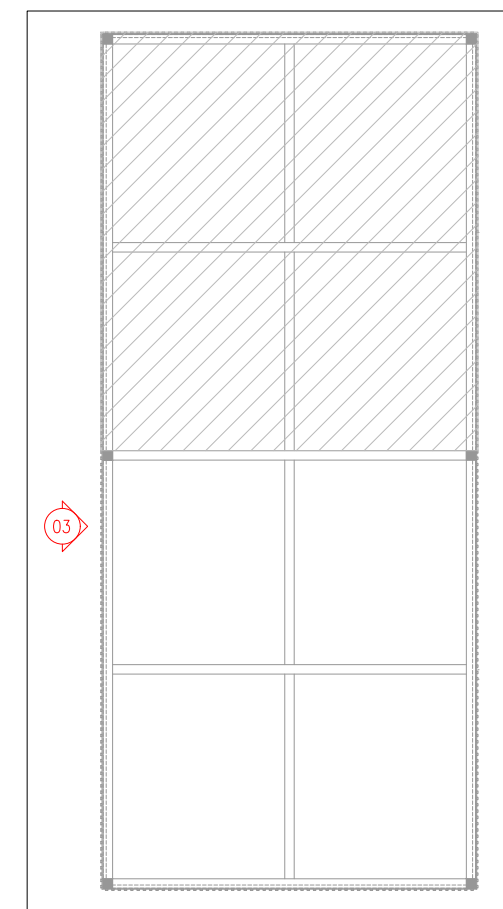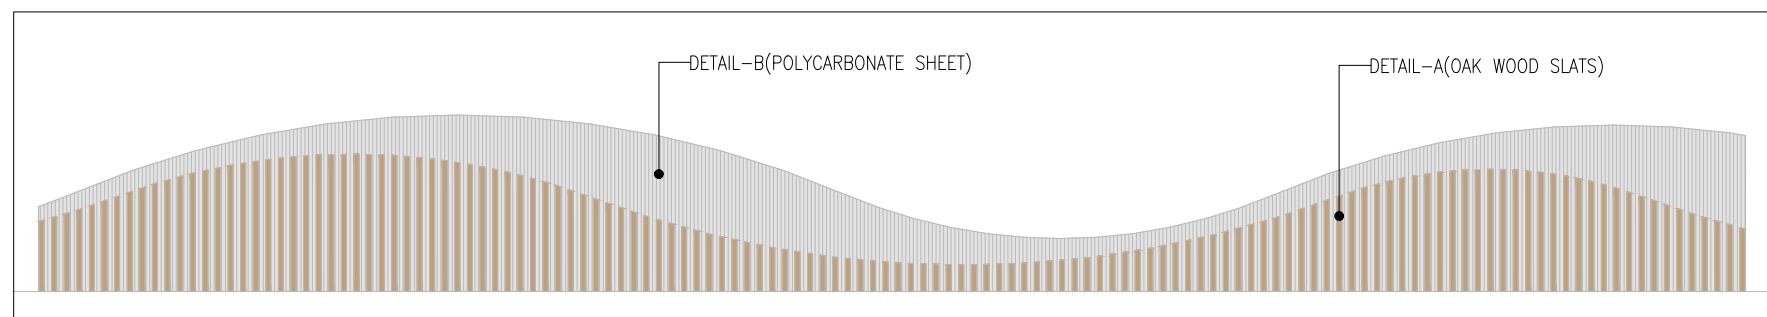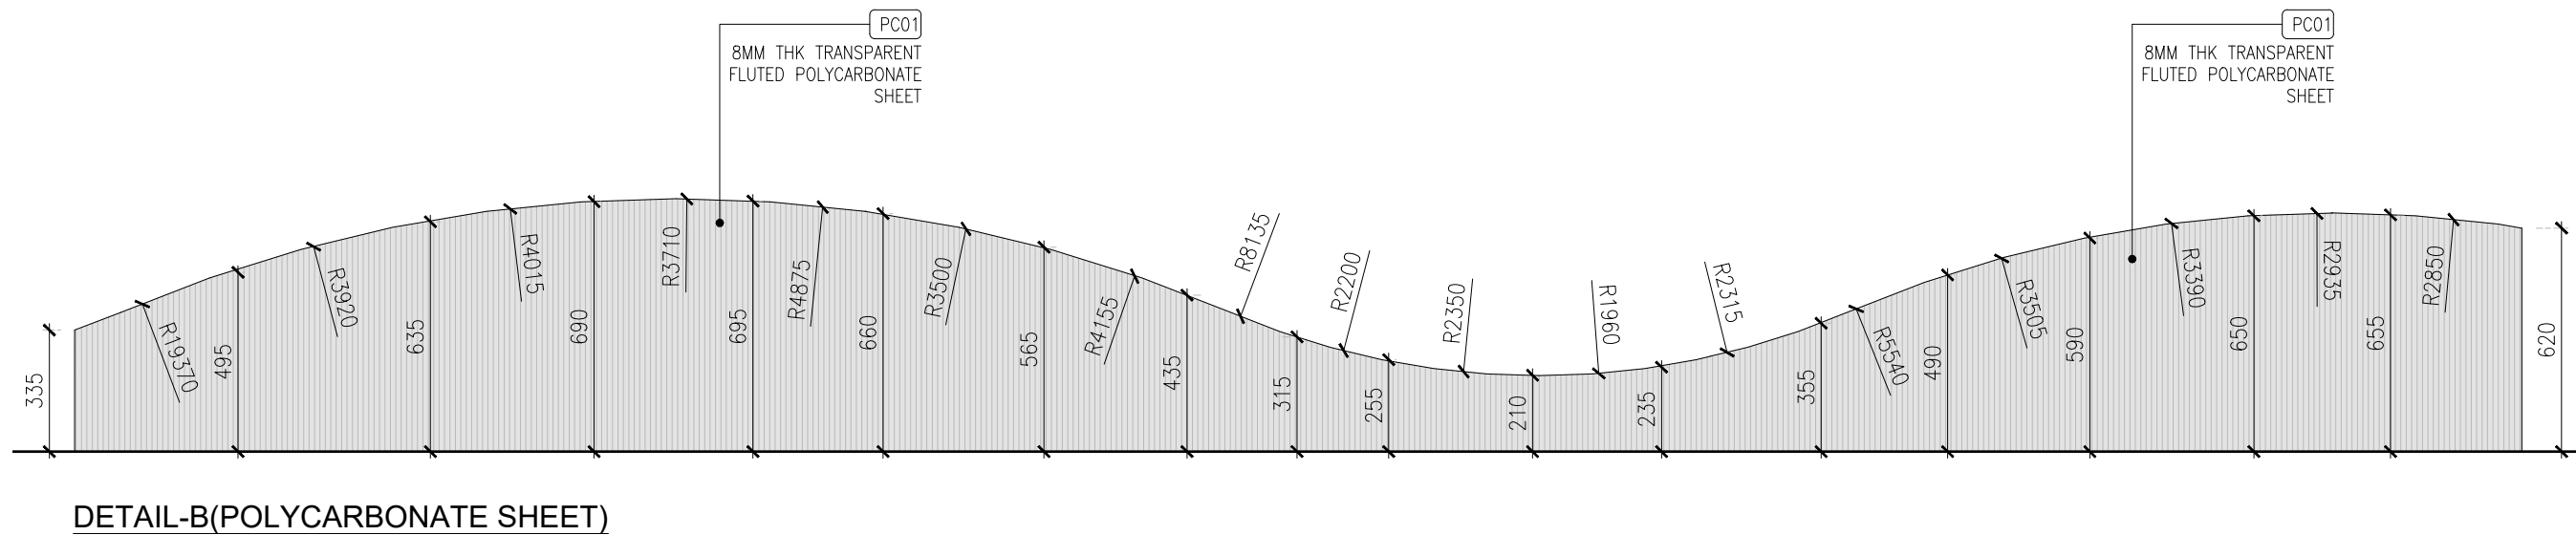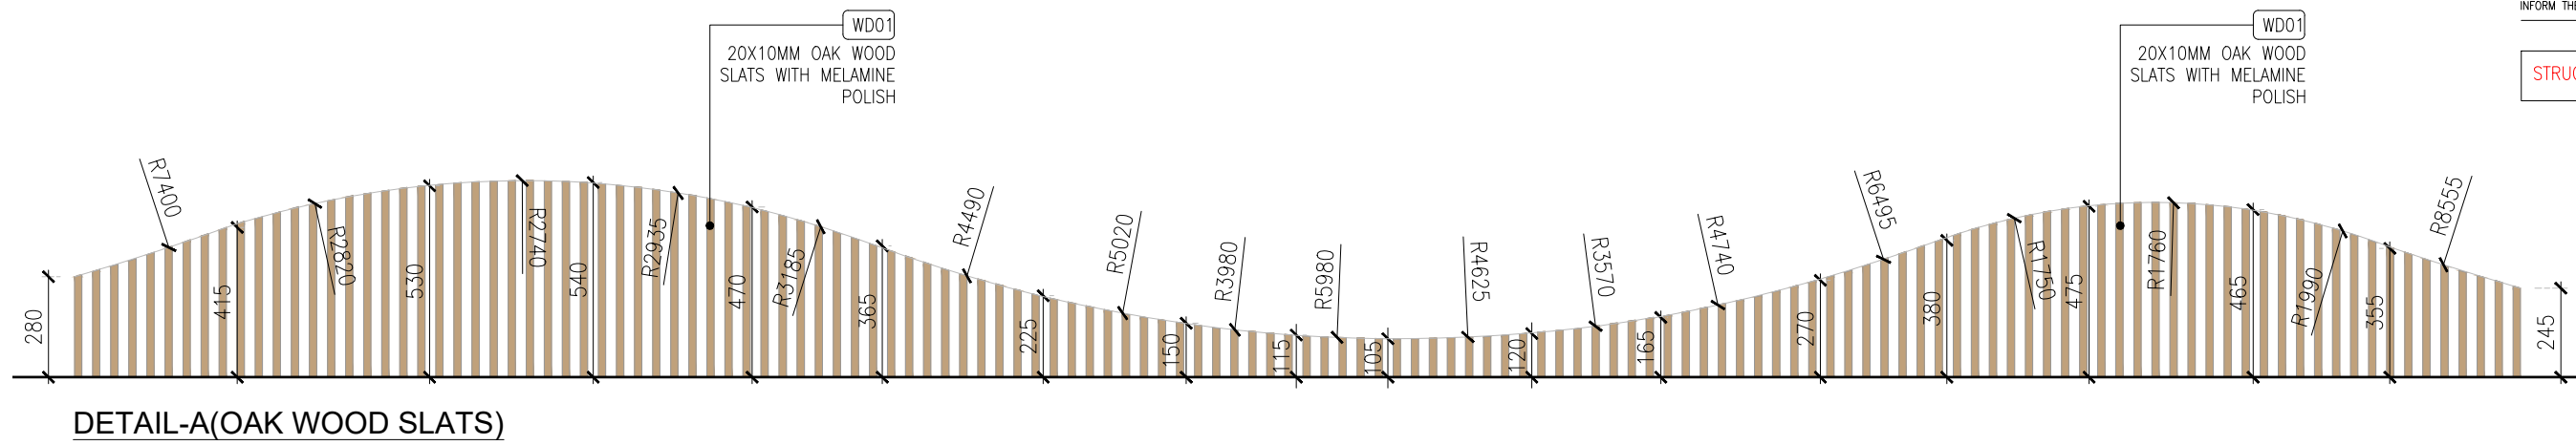

TO1	02.02.24	TENDER	HOD	NM
REV	DATE	DESCRIPTION	DRN	CHK



PROJECT
HATTI KAAPI FF52
GMR INTERNATIONAL
AIRPORT LIMITED,
HYDERABAD


DRAWING TITLE
J03-BULKHEAD DETAIL- PART:G

SCALE 1:20 DATE 02.02.2024 DRAWN HOD A3 SHEET


STATUS
TENDER

ORG PROJECT NO DRAWING TYPE NUMBER REV
TFS XXXX 04DE 410 T01


STRUCTURAL DETAILS ARE INDICATIVE ONLY

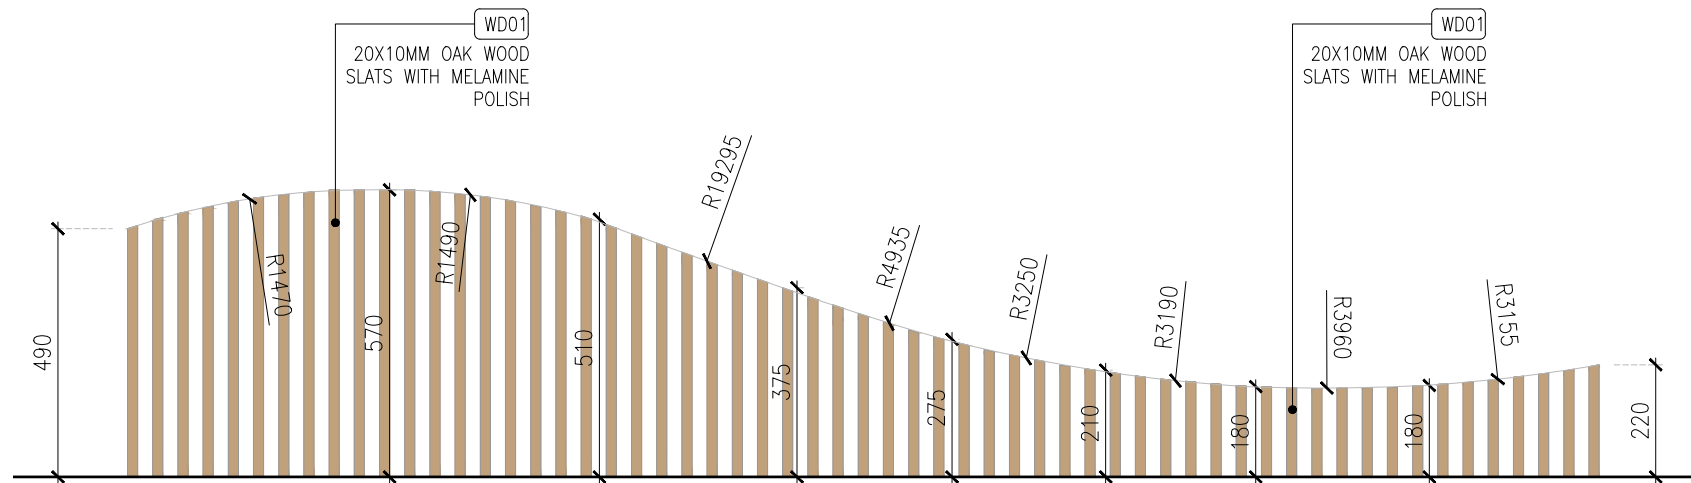

DETAIL-A(OAK WOOD SLATS)

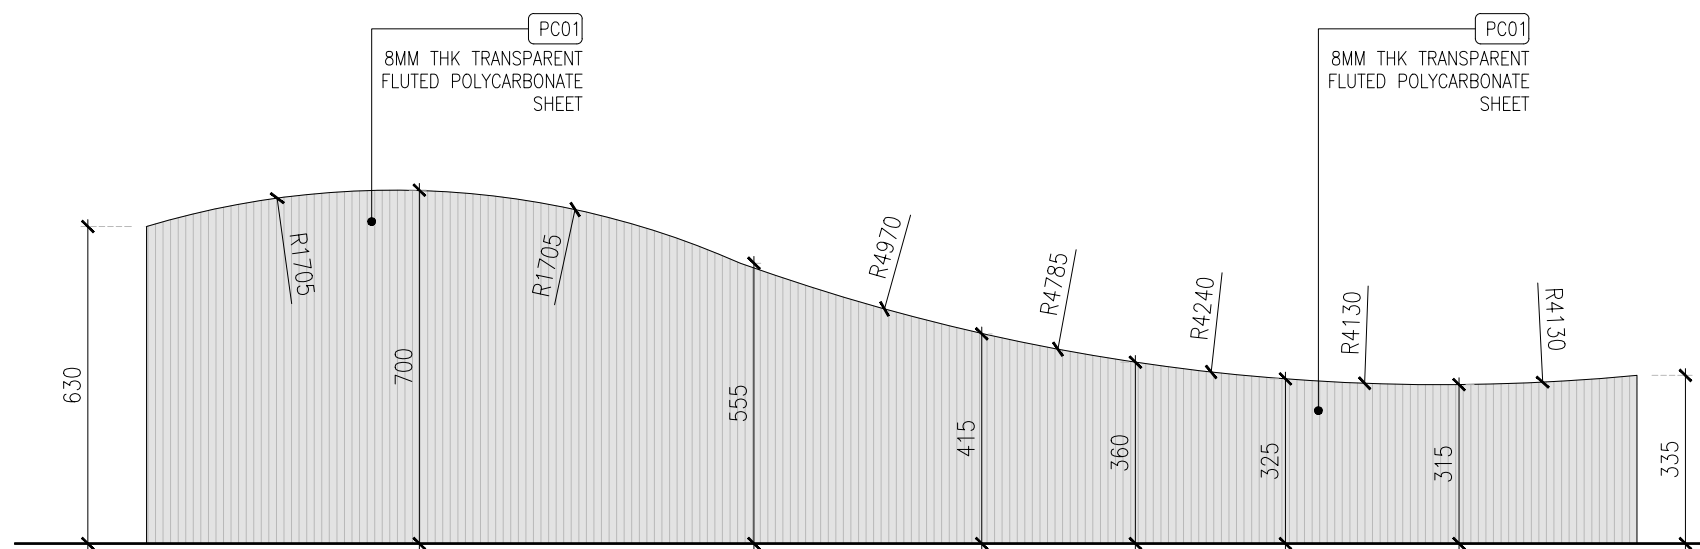


DETAIL-B(POLYCARBONATE SHEET)

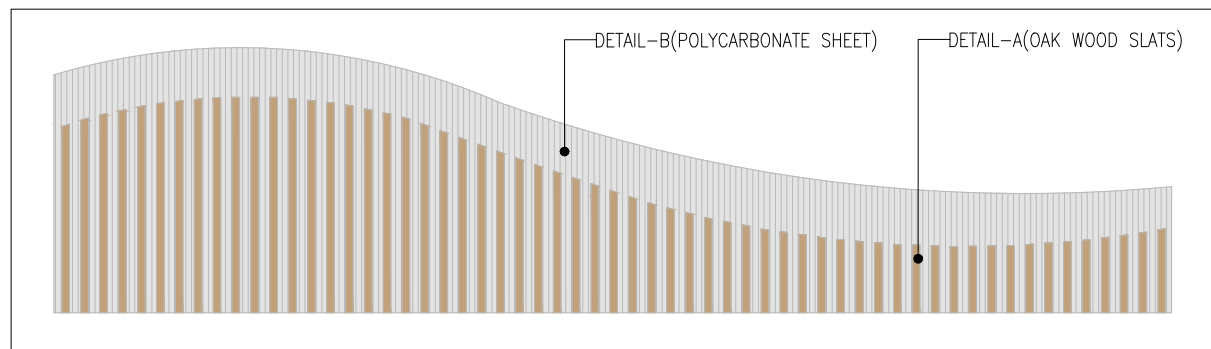

KEY PLAN(ELEVATION-03)

01 WOODEN SLATS & POLYCARBONATE SHEET DETAIL
04DE-411 1:15

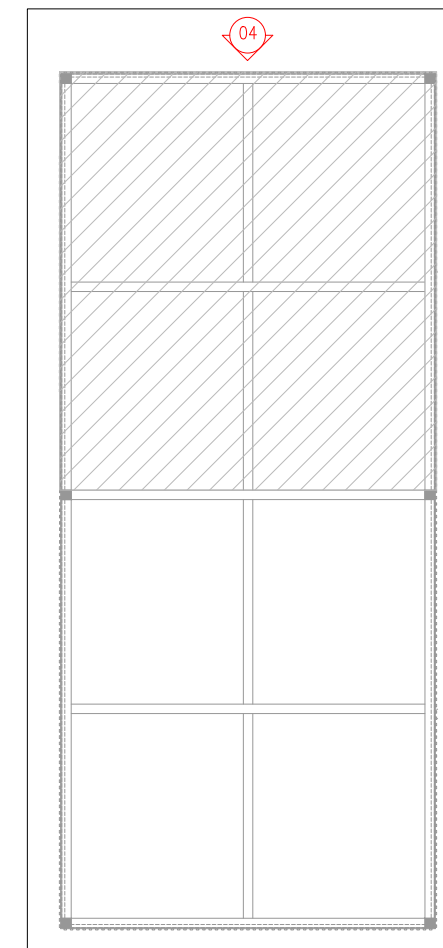

KEY PLAN

REV	DATE	DESCRIPTION	HOD	NM
T01	02.02.24	TENDER		
			DRN	CHK



PROJECT
HATTI KAAPI FF52
GMR INTERNATIONAL
AIRPORT LIMITED,
HYDERABAD


DRAWING TITLE
J03-BULKHEAD DETAIL- PART:H

SCALE 1:15 DATE 02.02.2024 DRAWN HOD A3 SHEET


STATUS
TENDER

ORG PROJECT NO DRAWING TYPE NUMBER REV
TFS XXXX 04DE 411 T01


STRUCTURAL DETAILS ARE INDICATIVE ONLY

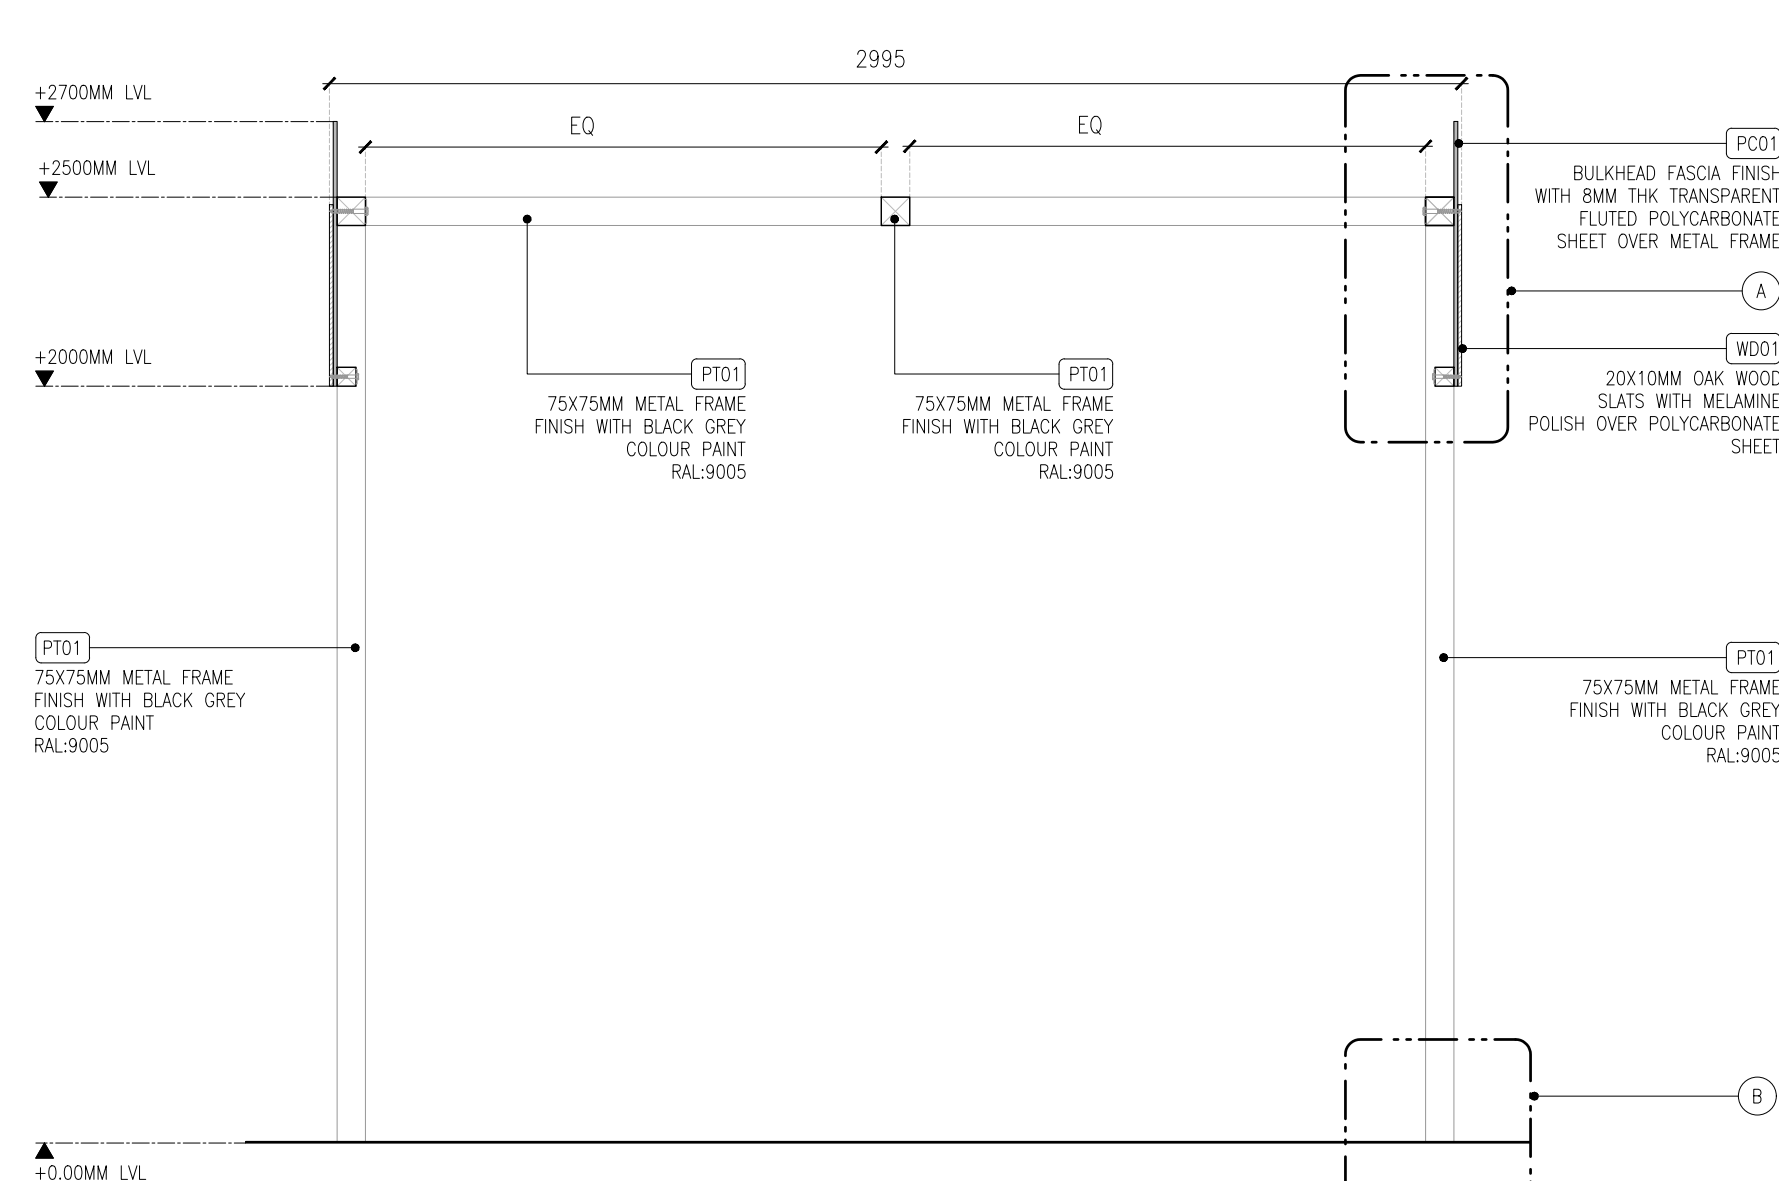


01 SECTION - 01
04DE-412 1:20

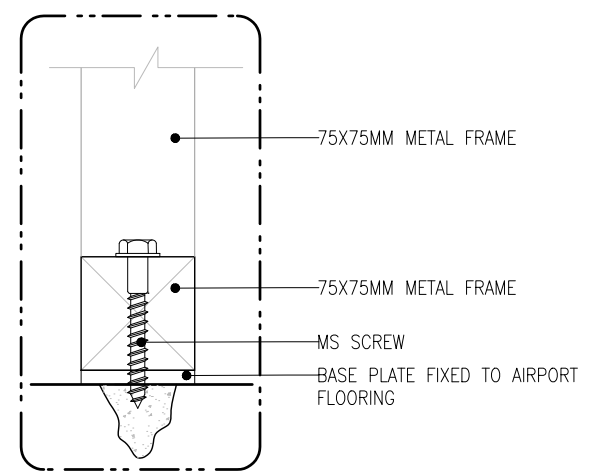

DETAIL-B (SCALE 1:5)

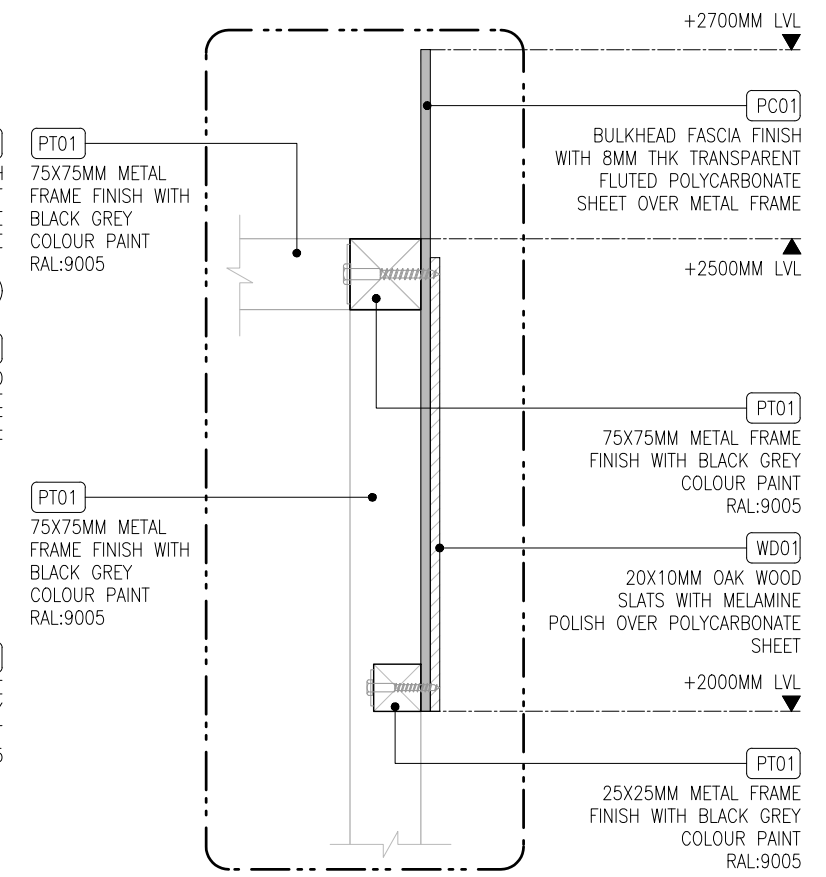

DETAIL-A (SCALE 1:10)

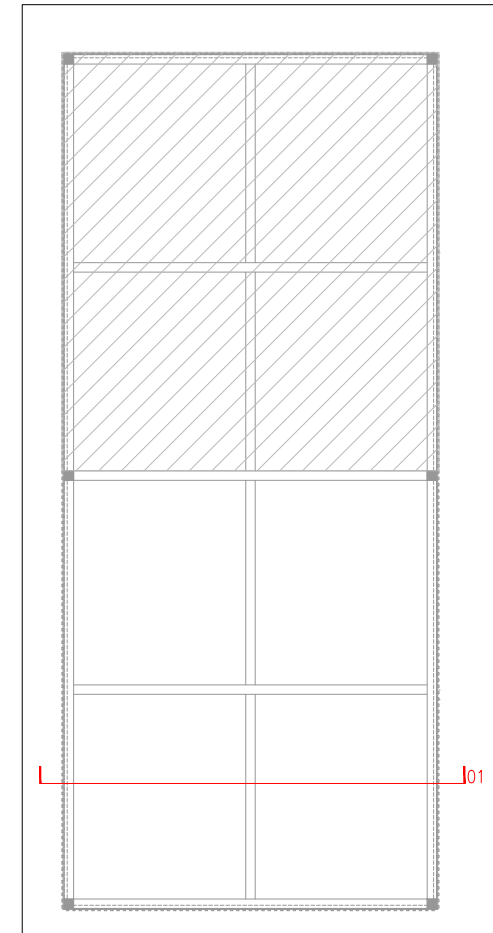

KEYPLAN

TO1	02.02.24	TENDER	HOD	NM
REV	DATE	DESCRIPTION	DRN	CHK





PROJECT
HATTI KAAPI FF52
GMR INTERNATIONAL
AIRPORT LIMITED,
HYDERABAD

DRAWING TITLE
J03-BULKHEAD DETAIL- PART:1


SCALE AS MENTIONED DATE 02.02.2024 DRAWN HOD A3 SHEET

STATUS
TENDER


ORG	PROJECT NO	DRAWING TYPE	NUMBER	REV
TFS	XXXX	04DE	412	T01

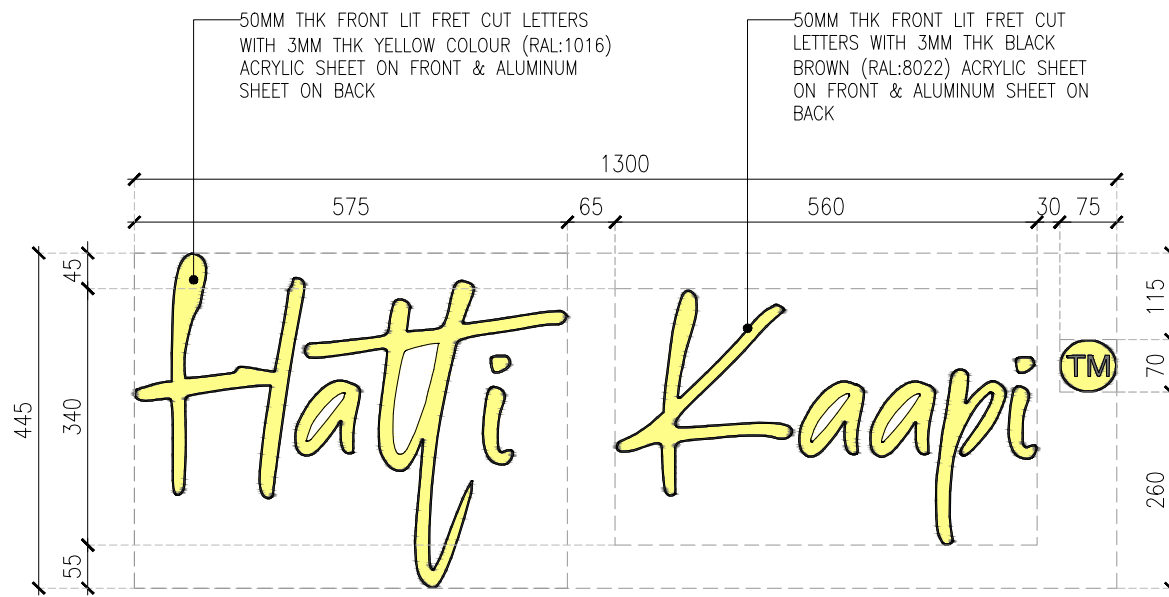 


01 LIT SIGNAGE-01 (SG01)(2NOS)
04DE-413 1:10

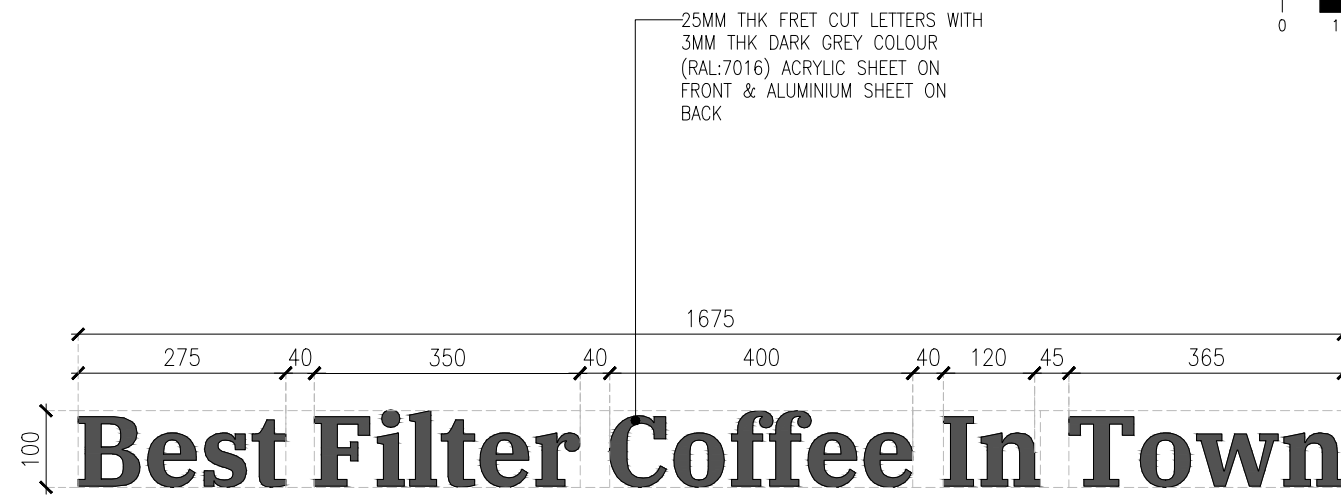


02 SIGNAGE-02 (SG02)
04DE-413 1:10

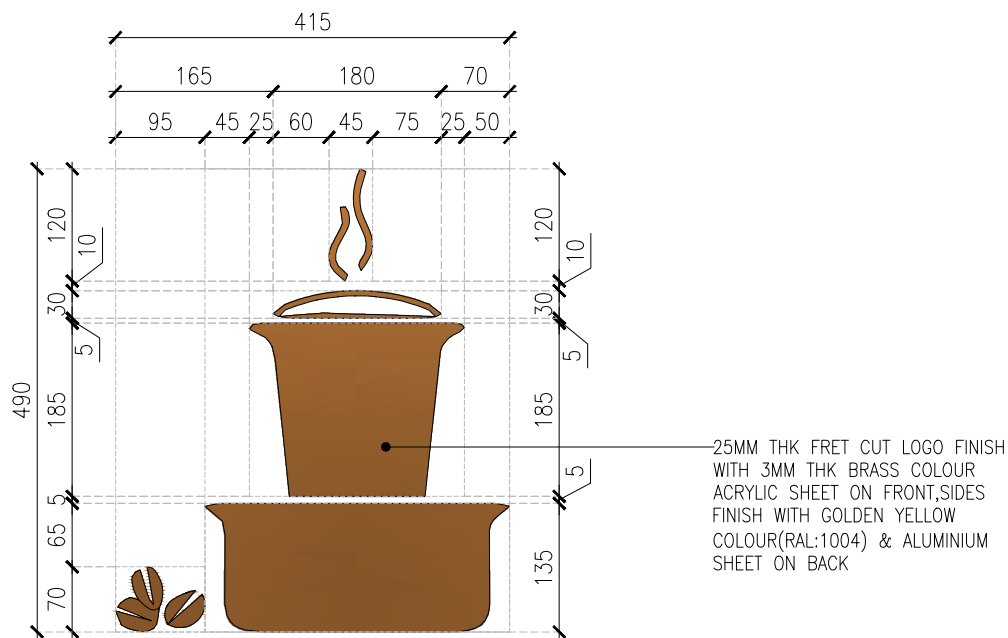

03 LOGO SIGNAGE-01 (LG01)(2NOS)
04DE-413 1:10

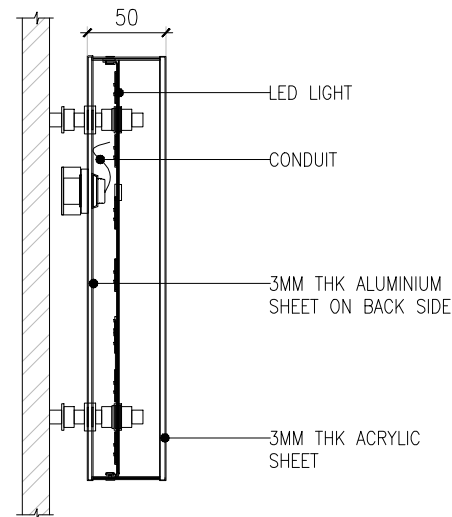

TYPICAL SECTION OF FRONT LIT SIGNAGE

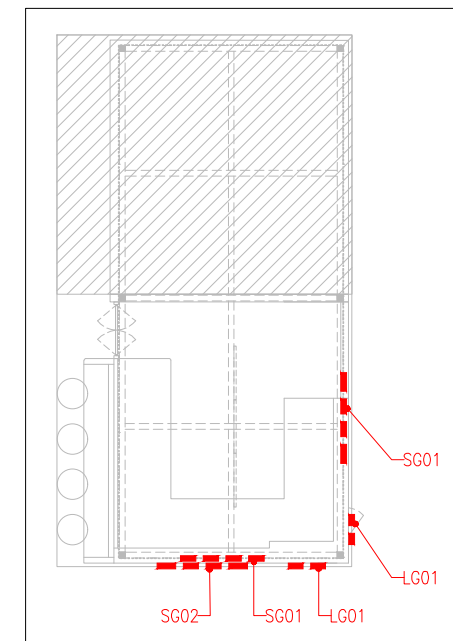

KEY PLAN

T01	02.02.24	TENDER		HOD	NM
REV	DATE	DESCRIPTION		DRN	CHK



PROJECT
HATTI KAAPI FF52
GMR INTERNATIONAL
AIRPORT LIMITED,
HYDERABAD

DRAWING TITLE
J05-SIGNAGE & LOGO DETAIL

SCALE	1:10	DATE	02.02.2024	DRAWN	HOD	A3	SHEET
-------	------	------	------------	-------	-----	----	-------

STATUS

TENDER

ORG	PROJECT NO	DRAWING TYPE	NUMBER	REV
TFS	XXXX	04DE	413	T01