



COLD ROOM DOOR WILL OPEN WHEN NO ONE IS STANDING AT SINK. IT'S PART OF SOP AFTER MAKING NON VEG PIZZA THE STAFF HAS TO WASH THIS BEFORE MAKING VEG PIZZA

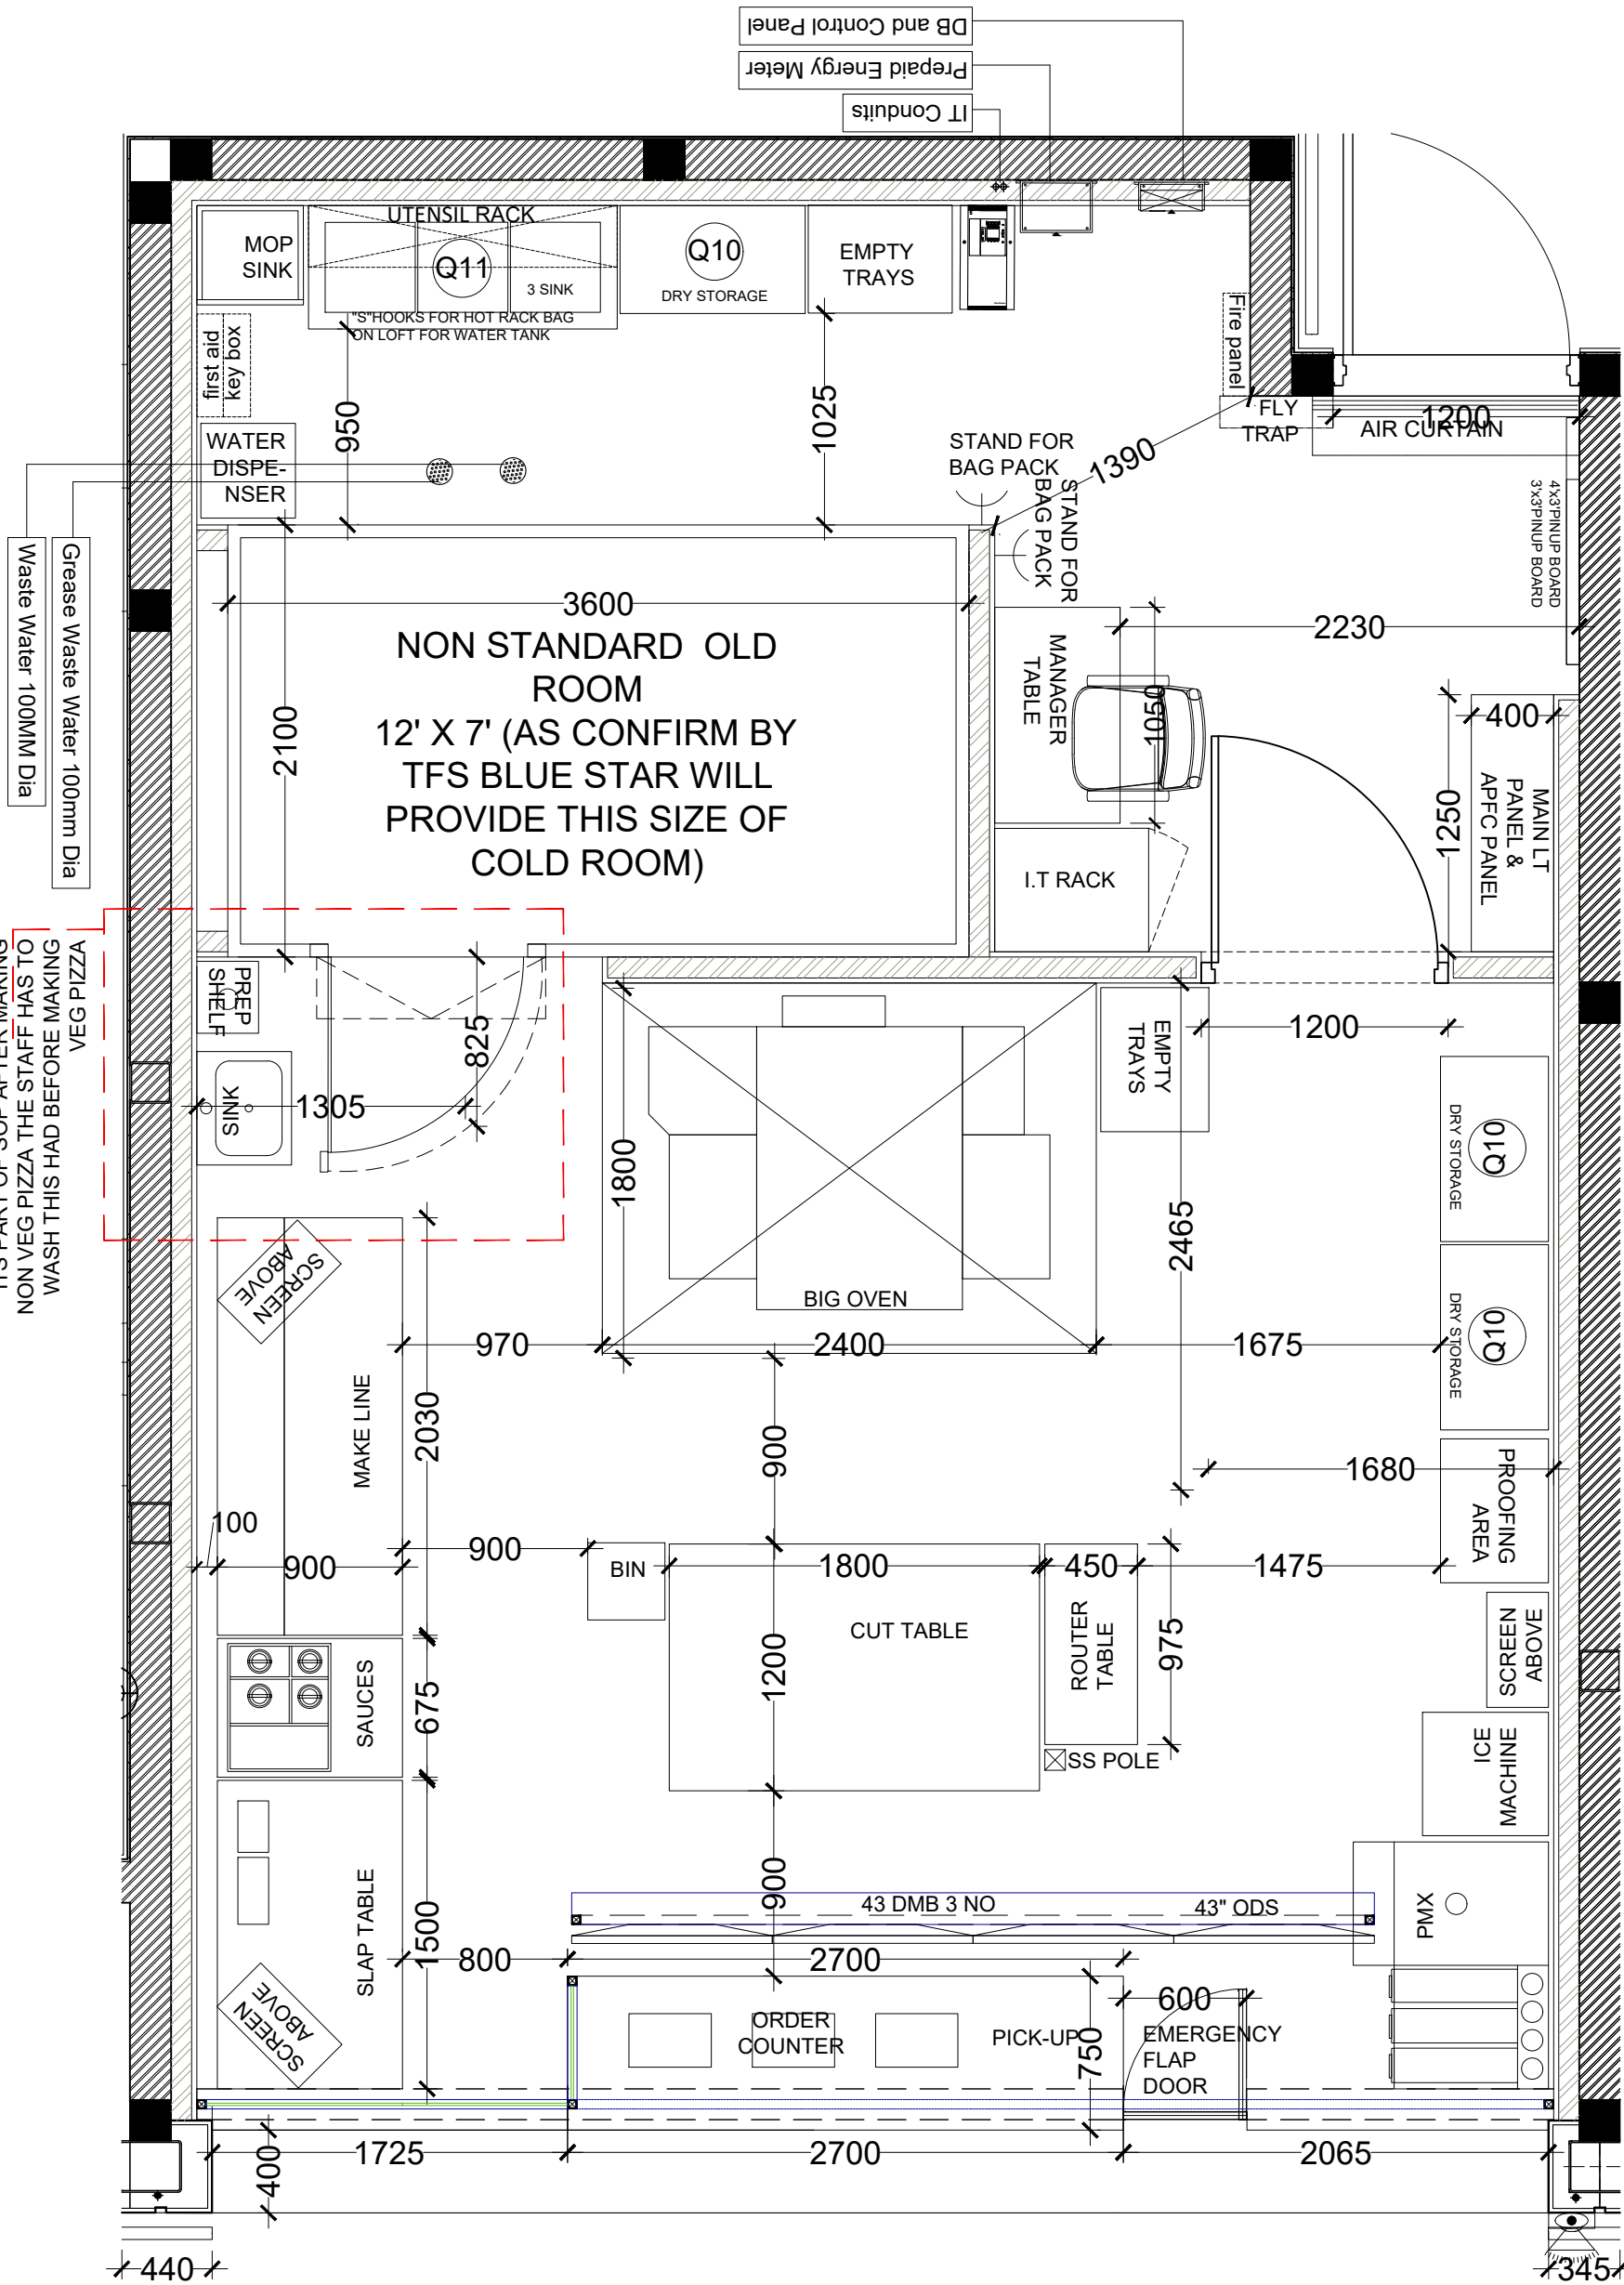



**Domino's
Pizza**

JUBILANT FOODWORKS LTD.
(DOMINO'S PIZZA INDIA LTD.)
LOGIX TECHNO PARK, PLOT NO. 5,
TOWER - D, 5th FLOOR,
SECTOR - 127, NOIDA-201304,
PHONE: 0120-4090500, 4090594.

THESE PLANS & SPECIFICATIONS AS WELL AS DOMINO'S NAME & LOGO, TRADEMARKS & DESIGNS ARE THE EXCLUSIVE PROPERTY OF JUBILANT COMPANY. ANY REPRODUCTION, MODIFICATION, DISCLOSURE AND/OR USE OF THESE MATERIALS OR BY PORTION OF THEM WITHOUT DOMINO'S PRIOR WRITTEN CONSENT IS STRICTLY PROHIBITED.

DISCLAIMER-
IN CASE OF ANY SITE DISCREPANCY,
PLEASE GET BACK TO CORPORATE
DESIGN TEAM

JUBILANT FOODWORKS
INDIA LTD.


PROJ	: GMR 1D DELHI
TOTAL AREA	: 670 SQFT
KITCHEN AREA	: 502 SQFT
BOH AREA	: 178 SQFT
ZONE	: NORTH
COUNTRY	: INDIA.

RESTAURANT NO.:

DRAWN BY	: VARUN
CHECKED BY	:
ISSUED ON	: 26-09-2023


REVISION NO.	REVISION DATE
1	11-10-2023
2	20-10-2023
3	27-10-2023
4	-2022

REMARKS : REVISED AS COMMENT
SCALE : NOT TO SCALE
SHEET NO. : 1
SHEET TITLE : PLAN

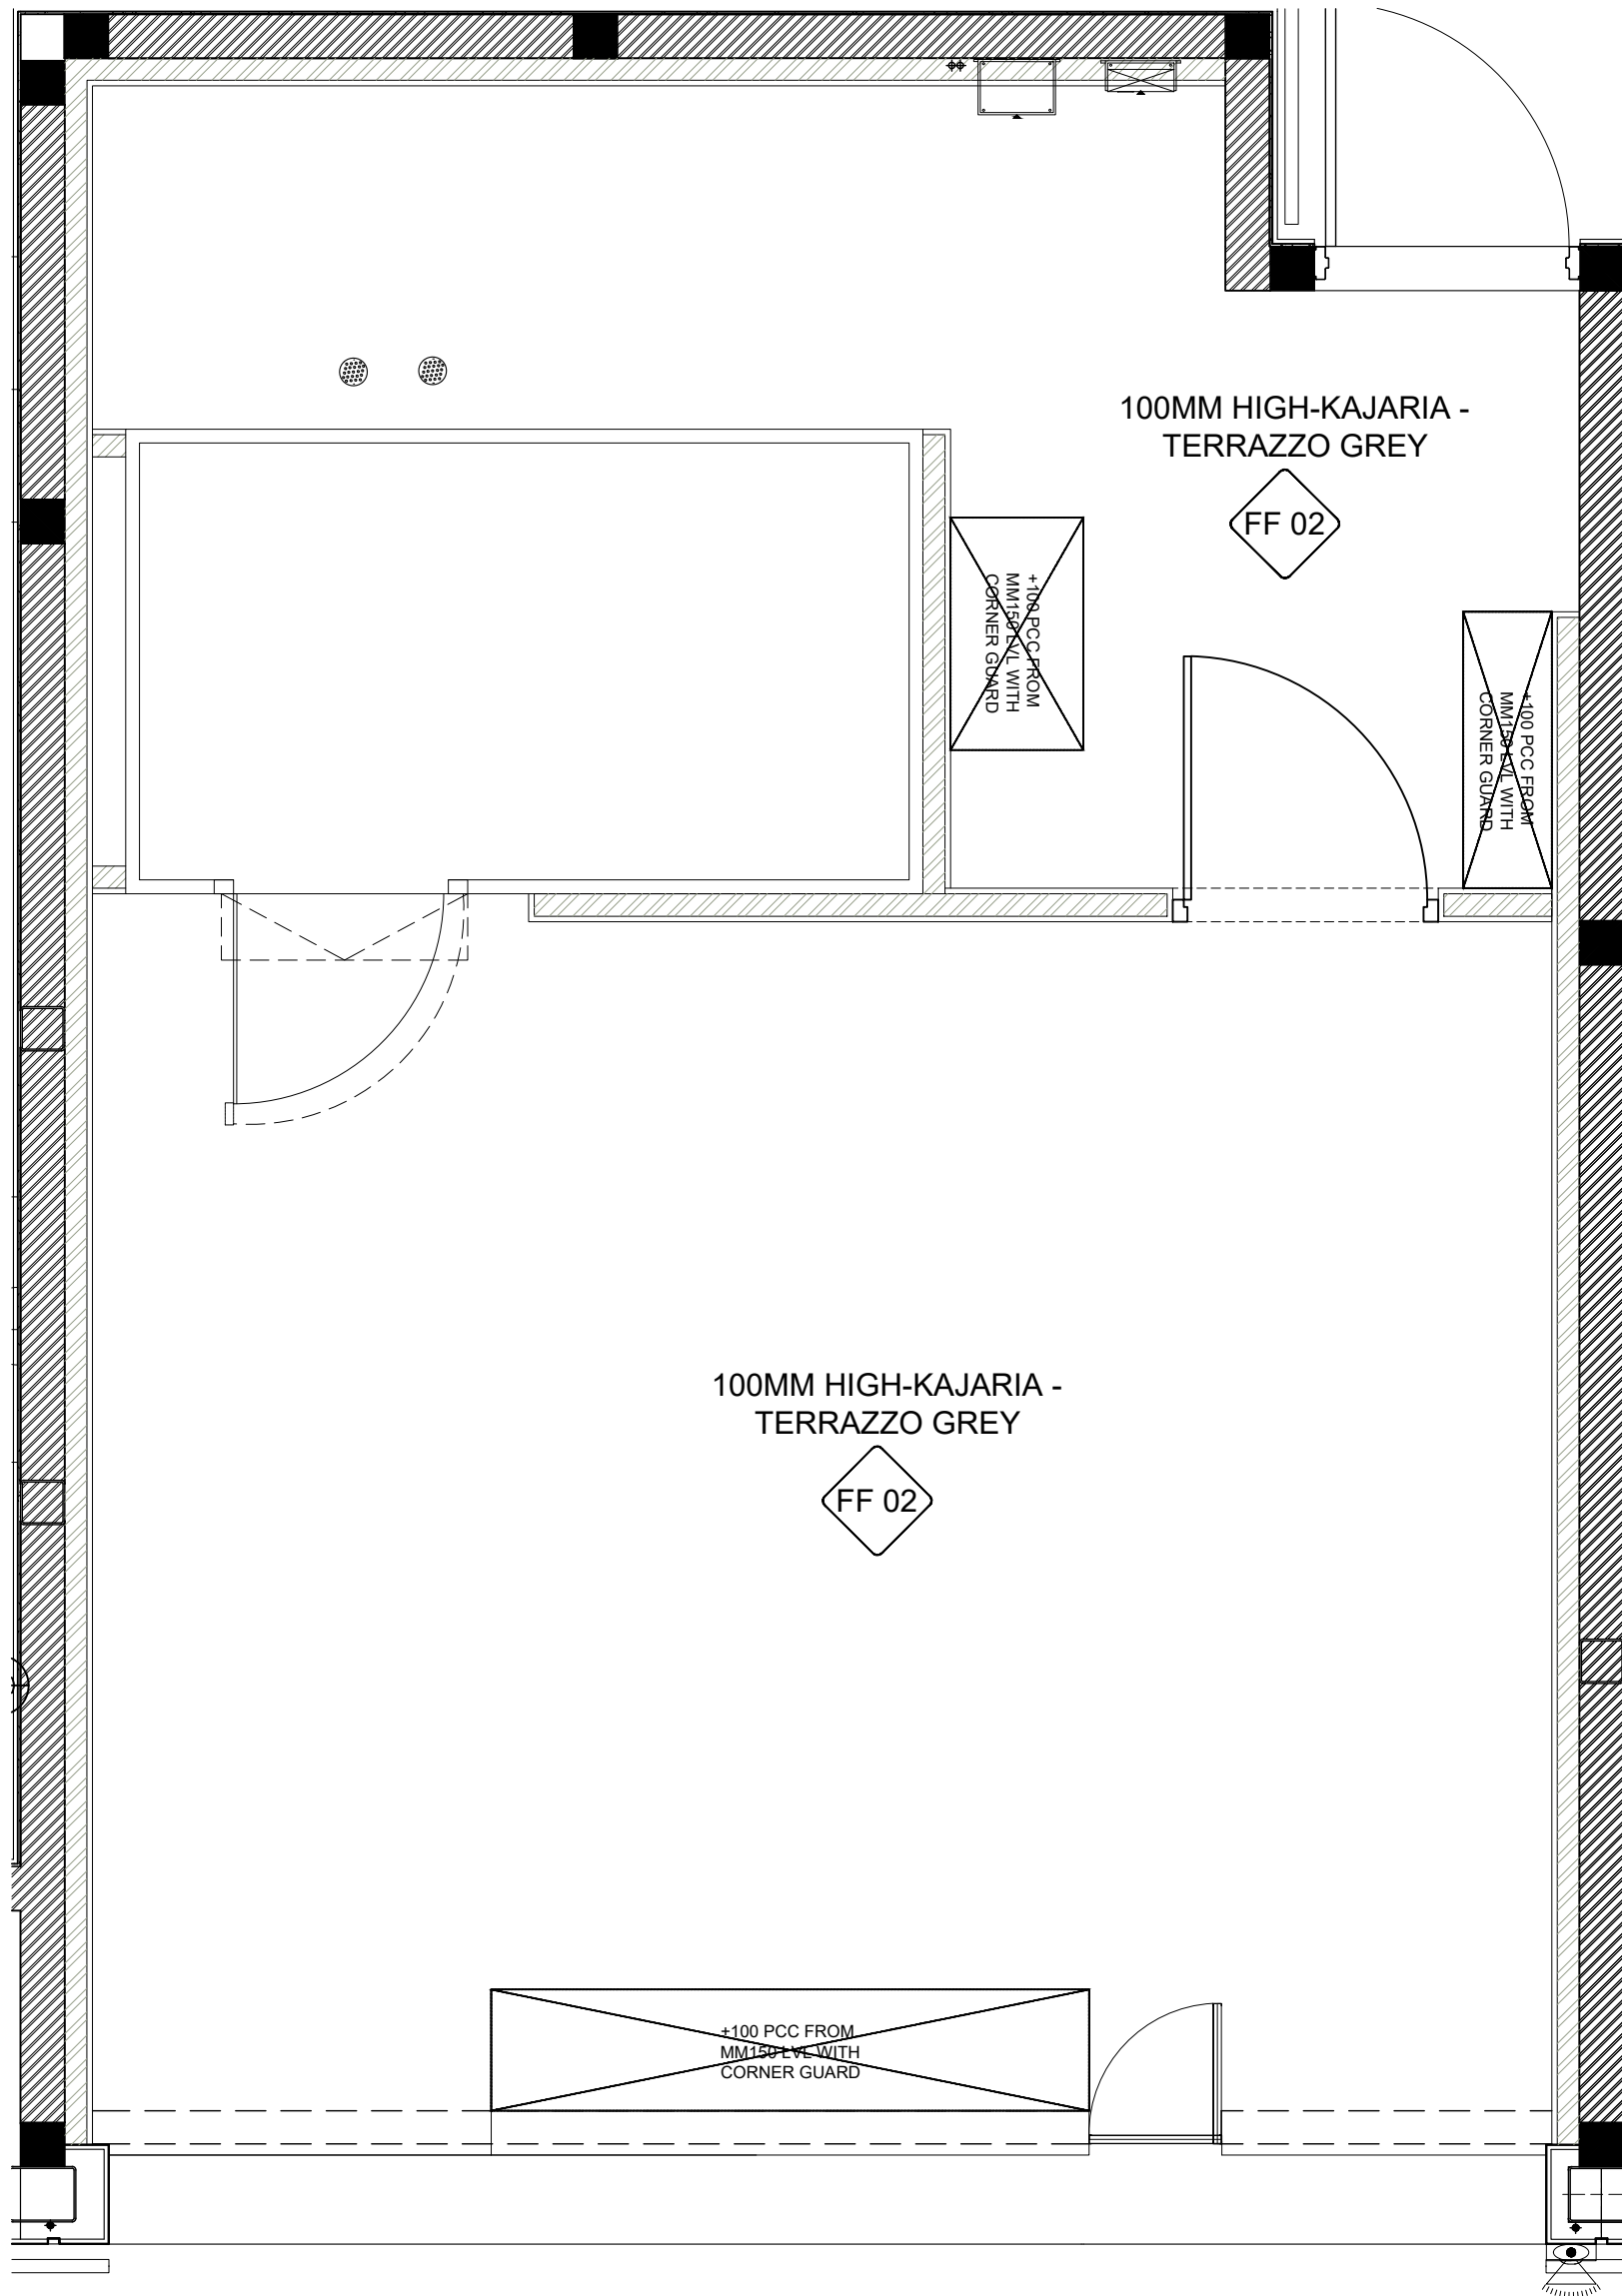

SKIRTING LEGEND (GROUND FLOOR)	
INDICATION	MAKE
FF 02	100MM HIGH-KAJARIA - TERRAZZO GREY

 NOTE : 1) SKIRTING TO BE FLUSHED TO FINISHED WALL, PARTITION & PANELING WITH 6X6MM GROOVE



**Domino's
Pizza**

JUBILANT FOODWORKS LTD.
(DOMINO'S PIZZA INDIA LTD.)
LOGIX TECHNO PARK, PLOT NO. 5,
TOWER - D, 5th FLOOR,
SECTOR - 127, NOIDA-201304,
PHONE: 0120-4090500, 4090594.

THESE PLANS & SPECIFICATIONS AS WELL AS DOMINO'S
NAME & LOGO, TRADEMARKS & DESIGNS ARE THE EXCLUSIVE
PROPERTY OF JUBILANT COMPANY. ANY REPRODUCTION,
MODIFICATION, DISCLOSURE AND/OR USE OF THESE
MATERIALS (OR BY PORTION OF THEM) WITHOUT DOMINO'S
PRIOR WRITTEN CONSENT IS STRICTLY PROHIBITED.

DISCLAIMER-
IN CASE OF ANY SITE DISCREPANCY,
PLEASE GET BACK TO CORPORATE
DESIGN TEAM

JUBILANT FOODWORKS
INDIA LTD.

PROJ : GMR 1D DELHI
TOTAL AREA : 670 SQFT
KITCHEN AREA : 502 SQFT
BOH AREA : 178 SQFT
ZONE : NORTH
COUNTRY : INDIA.


 
RESTAURANT NO. : .


DRAWN BY : VARUN
CHECKED BY :
ISSUED ON : 26-09-2023


REVISION NO.	REVISION DATE
1	11-10-2023
2	20-10-2023
3	27-10-2023
4	-2022

REMARKS : REVISED AS COMMENT
SCALE : NOT TO SCALE.
SHEET NO. : 3
SHEET TITLE : SKIRTING PLAN

FLOORING LEGEND

INDICATION	SIZE	MAKE
 FF 02	600 X 600	KAJARIA - TERRAZZO GREY
 FF 06		19MM THK STEEL GREY GRANITE AS/ SPECIFICATION

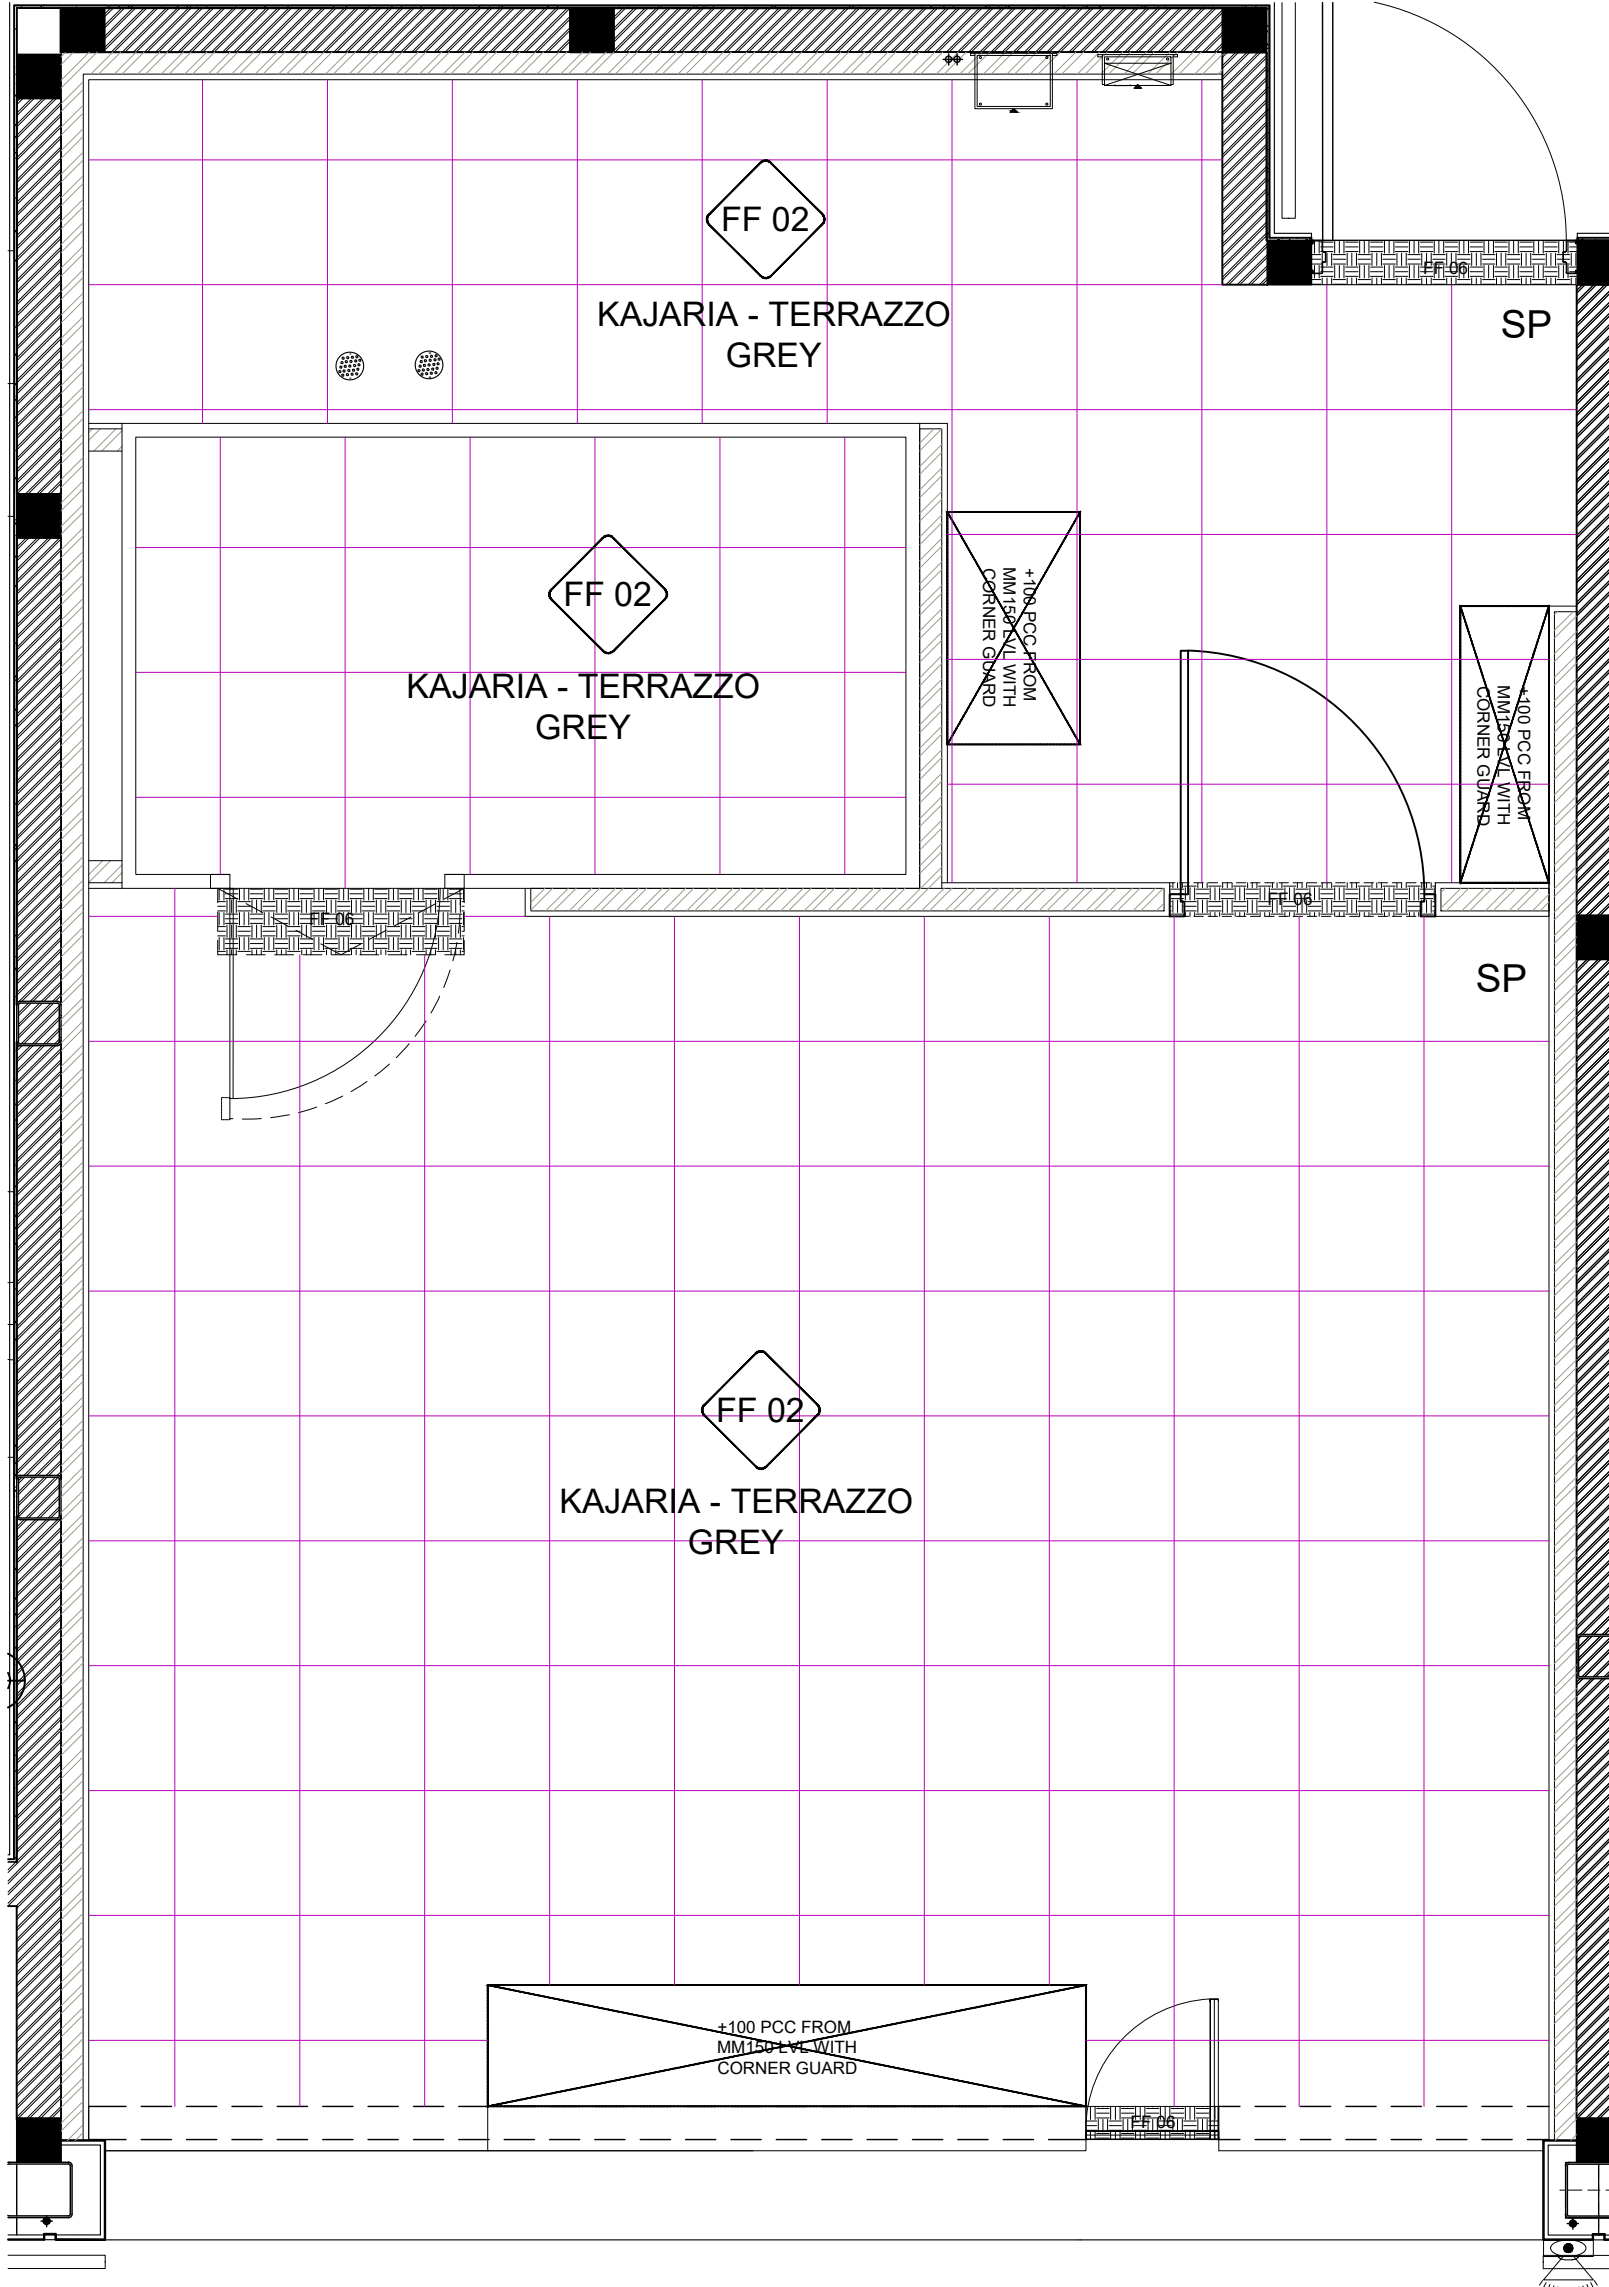



**Domino's
Pizza**

JUBILANT FOODWORKS LTD.
(DOMINO'S PIZZA INDIA LTD.)
LOGIX TECHNO PARK, PLOT NO. 5,
TOWER - D, 5th FLOOR,
SECTOR - 127, NOIDA-201304,
PHONE: 0120-4090500, 4090594.

THESE PLANS & SPECIFICATIONS AS WELL AS DOMINO'S NAME & LOGO, TRADEMARKS & DESIGNS ARE THE EXCLUSIVE PROPERTY OF JUBILANT COMPANY. ANY REPRODUCTION, MODIFICATION, DISCLOSURE AND/OR USE OF THESE MATERIALS (OR BY PORTION OF THEM) WITHOUT DOMINO'S PRIOR WRITTEN CONSENT IS STRICTLY PROHIBITED.

DISCLAIMER-
IN CASE OF ANY SITE DISCREPANCY,
PLEASE GET BACK TO CORPORATE
DESIGN TEAM

JUBILANT FOODWORKS
INDIA LTD.

PROJ	: GMR 1D DELHI
TOTAL AREA	: 670 SQFT
KITCHEN AREA	: 502 SQFT
BOH AREA	: 178 SQFT
ZONE	: NORTH
COUNTRY	: INDIA.

RESTAURANT NO.: .

DRAWN BY	: VARUN
CHECKED BY	:
ISSUED ON	: 26-09-2023
REVISION NO.	REVISION DATE
1	11-10-2023
2	20-10-2023
3	27-10-2023
4	-2022

REMARKS : REVISED AS COMMENT


SCALE : NOT TO SCALE.


SHEET NO. : 4

SHEET TITLE : FLOORING PLAN

NOTE:- ALL FURNITURE
WILL BE LAM-01

STANDARD SCHEDULE OF MATERIALS			
MATERIAL CODE	MATERIALS	FINISH / COLOUR	VENDOR / SUPPLIER
PAINTS, LAMINATES & VENEER			
PT-01	Paint	COAL MINE 8301 ON CEILING	Asian Paints
PT-02	Paint	COAL MINE 8301 HEIGHT AS PER ELEVATION TILL CEILING /SLAB	Asian Paints
LAM 01	Laminate	LOUISIANA OAK-5082	Greenlam
TL 01	600MM X 300MM TILE	CUSTOMIZED PRINTED TILE CLADDING AS PER ELEVATION FROM FFL(KITCHEN AREA)	Johnson
TL 02	600MM X 300MM TILE	PLAIN BASE TILE OF PRINTED TILE TILL HEIGHT AS PER ELEVATION FROM FFL(BOH AREA)	Johnson
TL 03	600MM X 300MM TILE	PLAIN BASE TILE OF PRINTED TILE TILL COUNTER HT FROM FFL (AT COUNTER)	Johnson
PT-03	Paint	GRAPHITE BLACK RAL 9011 (METAL WORK) ASIAN PAINTS (WOODTECH SPECTRA)	Asian Paints

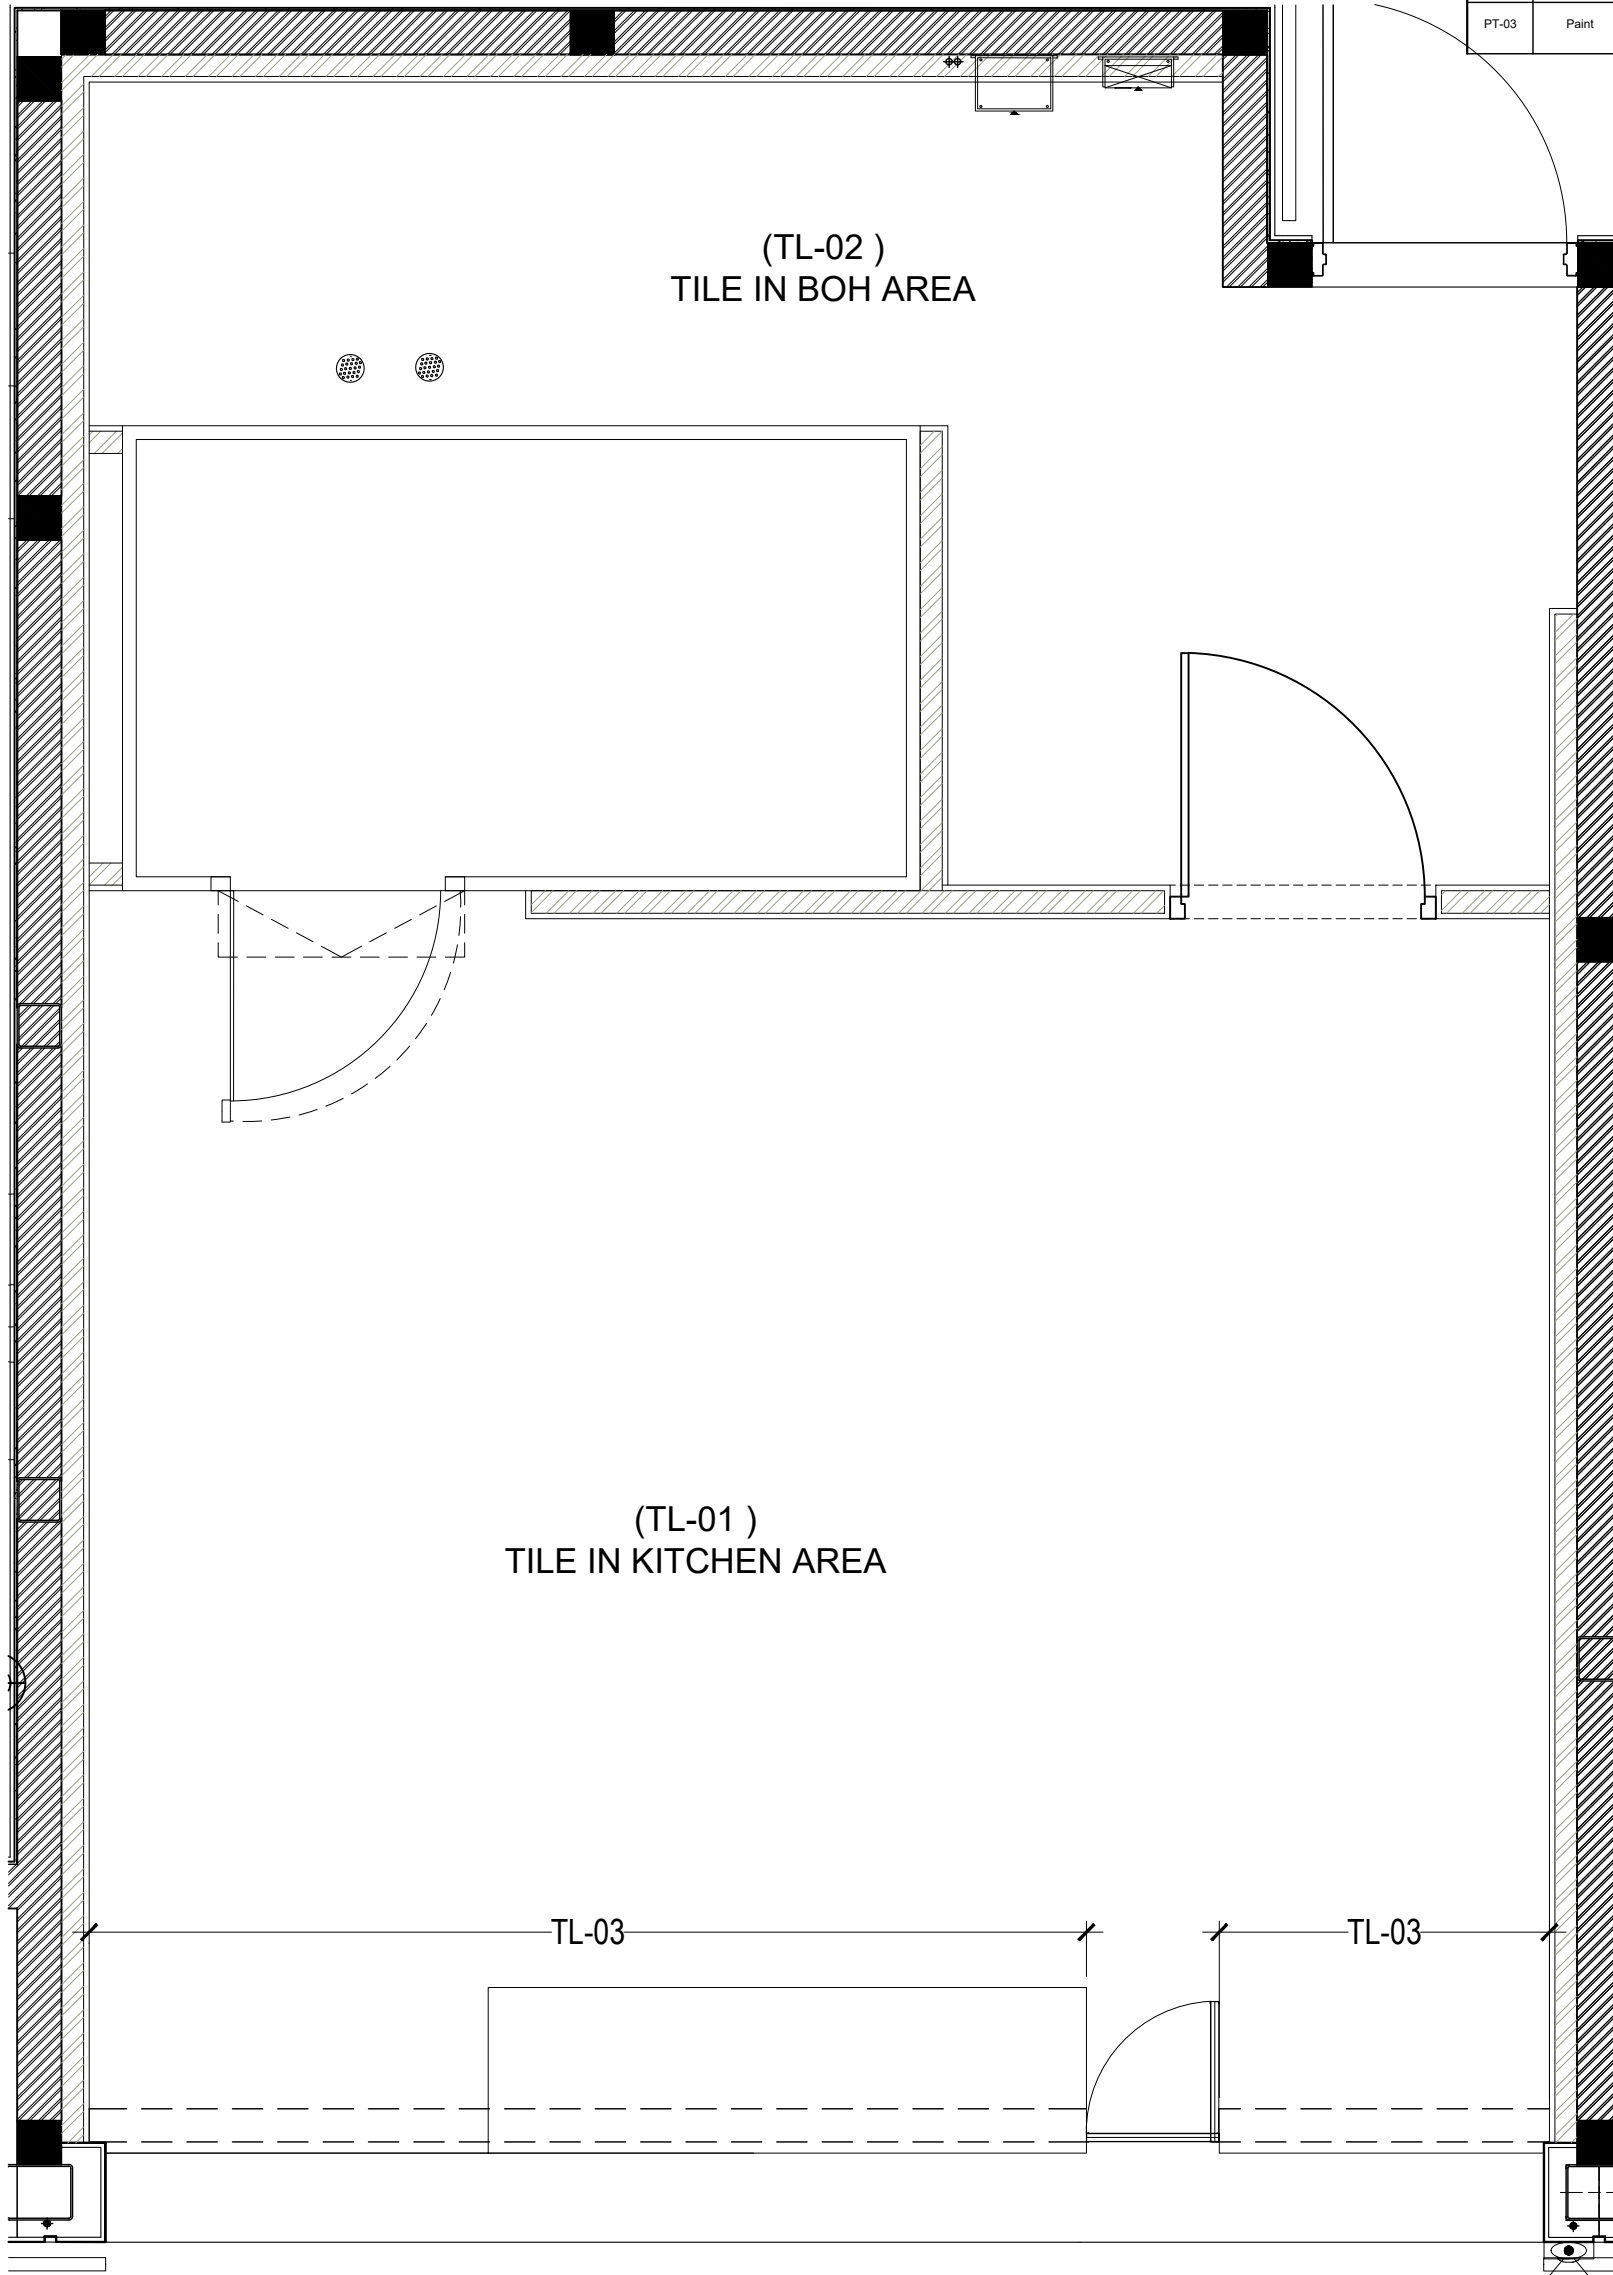

 

**Domino's
Pizza**

JUBILANT FOODWORKS LTD.
(DOMINO'S PIZZA INDIA LTD.)
LOGIX TECHNO PARK, PLOT NO. 5,
TOWER - D, 5th FLOOR,
SECTOR - 127, NOIDA-201304.
PHONE: 0120-4090500, 4090594.

THESE PLANS & SPECIFICATIONS AS WELL AS DOMINO'S NAME & LOGO, TRADEMARKS & DESIGNS ARE THE EXCLUSIVE PROPERTY OF JUBILANT COMPANY. ANY REPRODUCTION, MODIFICATION, DISCLOSURE AND/OR USE OF THESE MATERIALS (OR BY PORTION OF THEM) WITHOUT DOMINO'S PRIOR WRITTEN CONSENT IS STRICTLY PROHIBITED.

DISCLAIMER-
IN CASE OF ANY SITE DISCREPANCY,
PLEASE GET BACK TO CORPORATE
DESIGN TEAM

JUBILANT FOODWORKS
INDIA LTD.

PROJ : GMR 1D DELHI
TOTAL AREA : 670 SQFT
KITCHEN AREA : 502 SQFT
BOH AREA : 178 SQFT
ZONE : NORTH
COUNTRY : INDIA.


RESTAURANT NO.:


DRAWN BY : VARUN
CHECKED BY :
ISSUED ON : 26-09-2023

REVISION NO.	REVISION DATE
1	11-10-2023
2	20-10-2023
3	27-10-2023
4	-2022

REMARKS : REVISED AS COMMENT
SCALE : NOT TO SCALE.
SHEET NO. : 5
SHEET TITLE : WALL DECORATION PLAN

STANDARD SCHEDULE OF MATERIALS			
MATERIAL CODE	MATERIALS	FINISH / COLOUR	VENDOR / SUPPLIER
PT-01	Paint	COAL MINE 8301 ON CEILING	Asian Paints
PT-02	Paint	COAL MINE 8301 HEIGHT AS PER ELEVATION TILL CEILING /SLAB	Asian Paints
PT-03	Paint	GRAPHITE BLACK RAL 9011 (METAL WORK) ASIAN PAINTS (WOODTECH SPECTRA)	Asian Paints

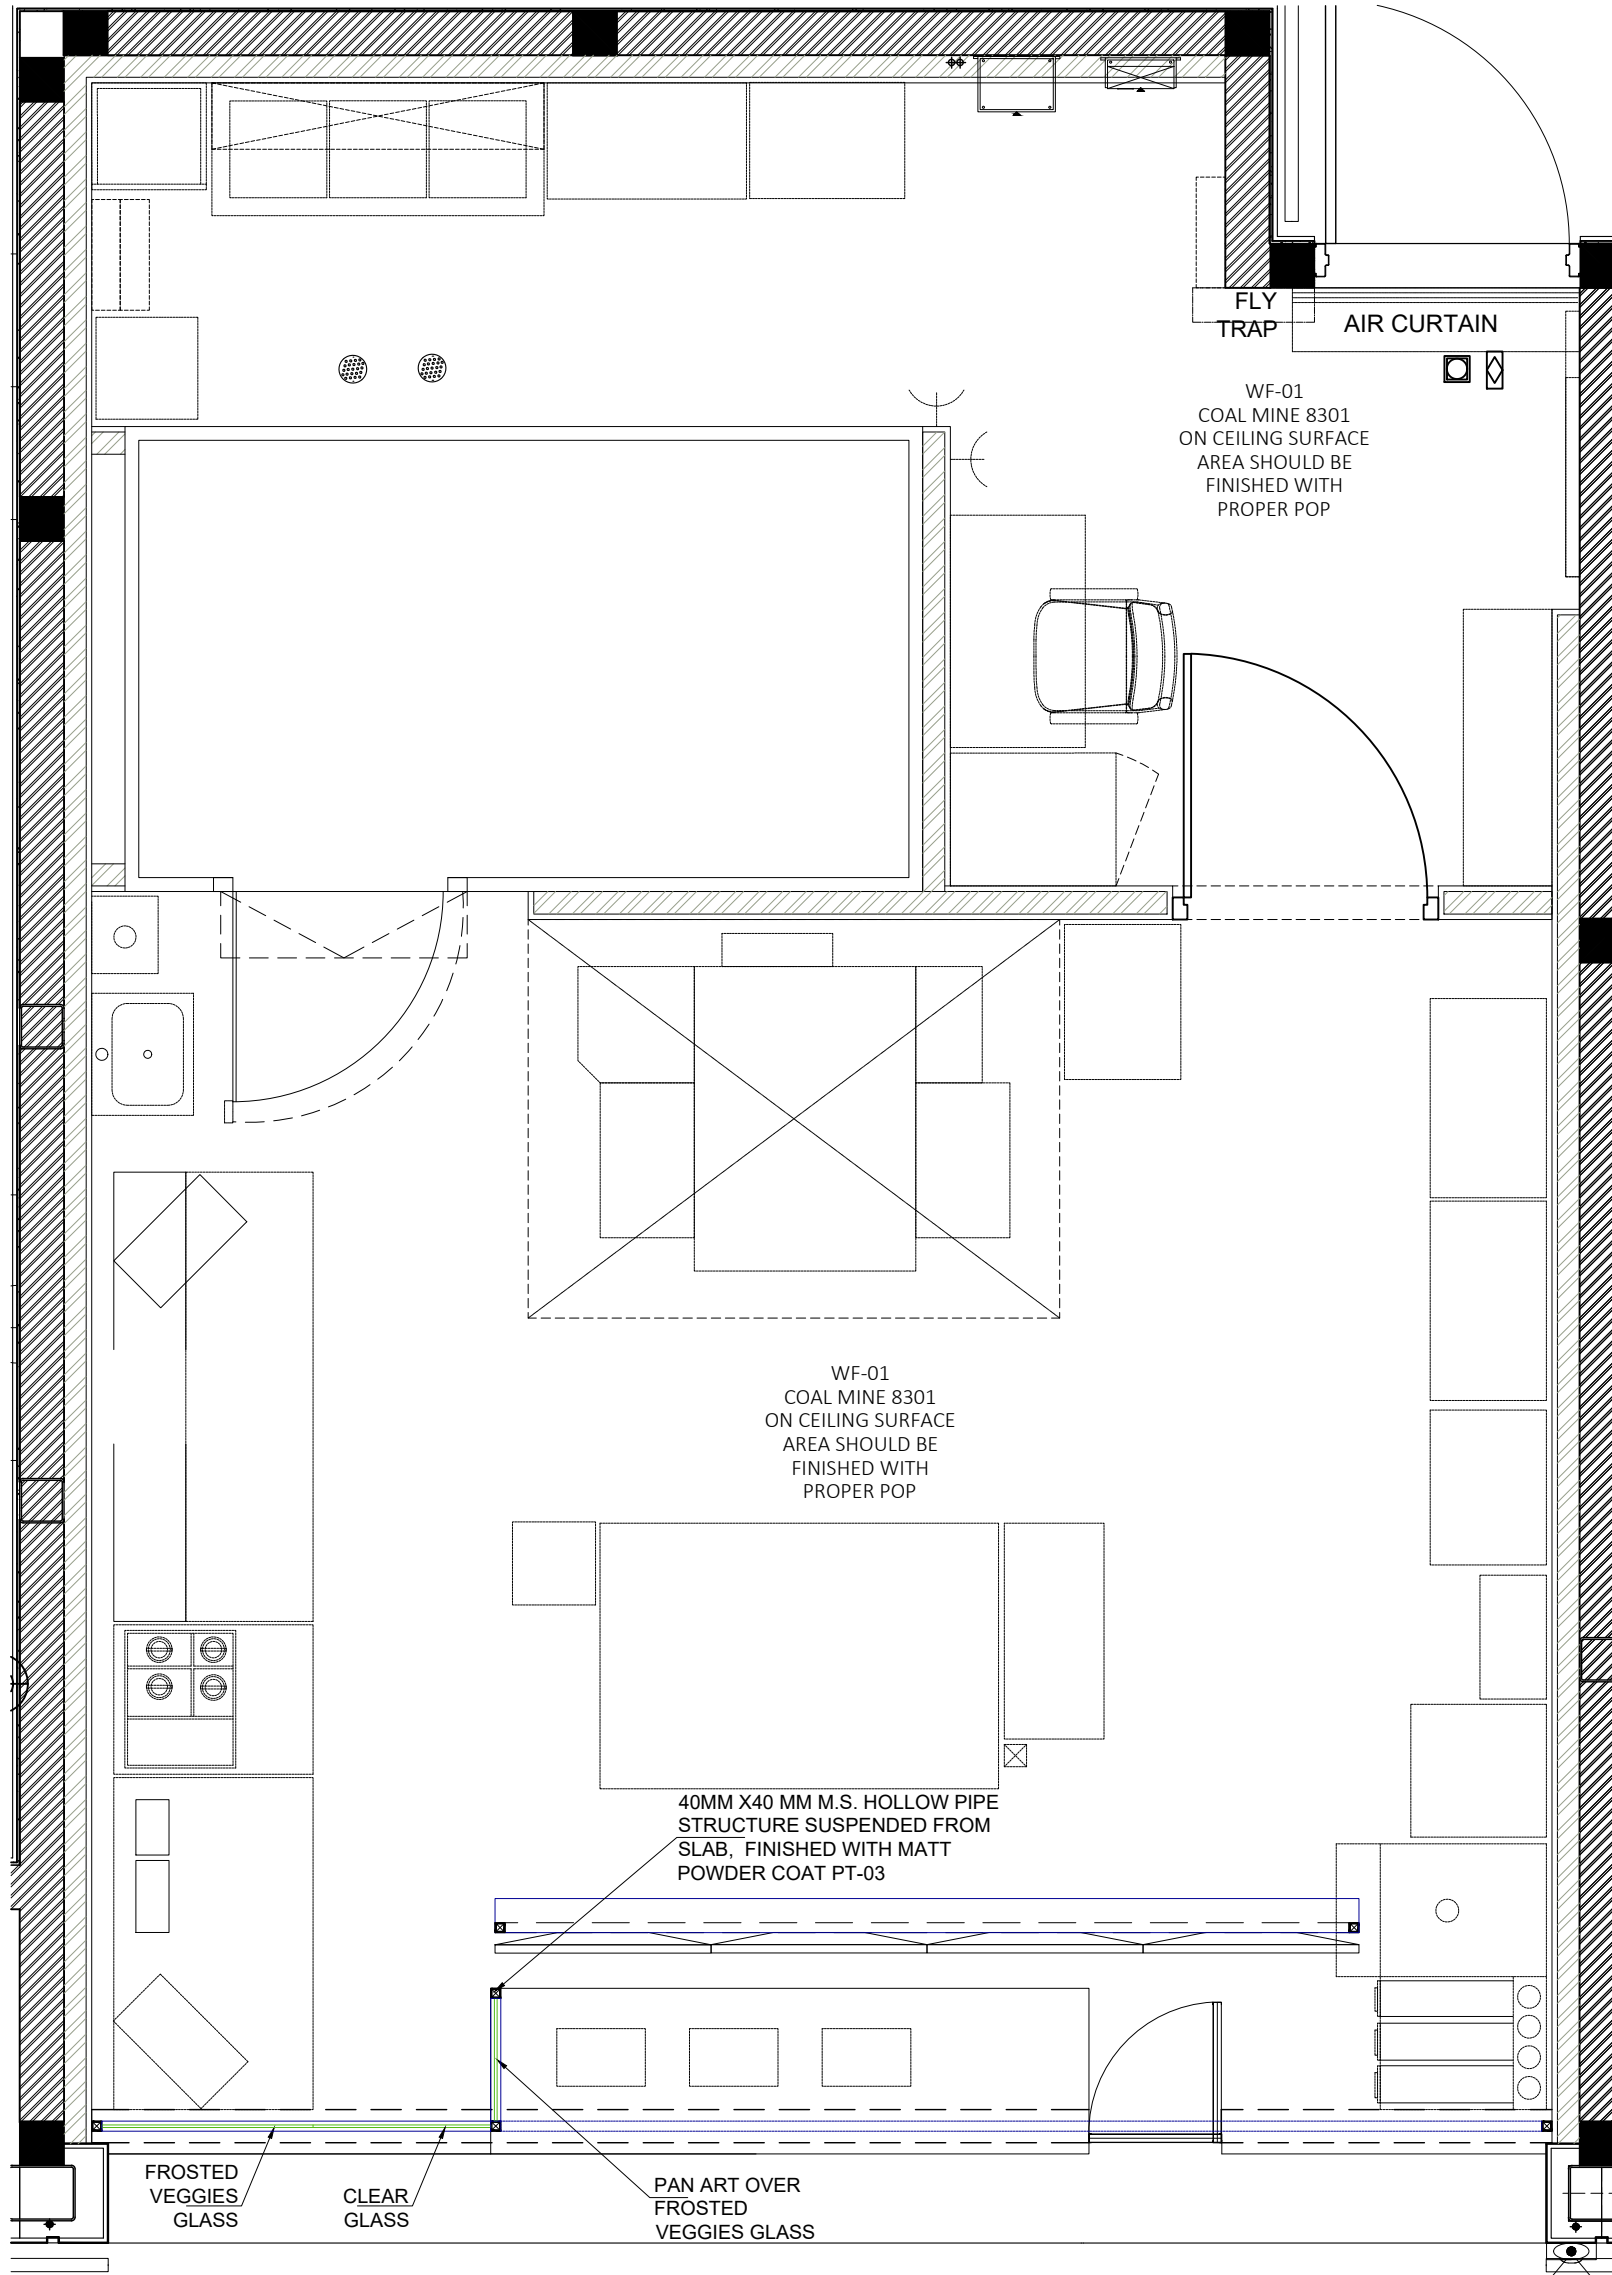



**Domino's
Pizza**

JUBILANT FOODWORKS LTD.
(DOMINO'S PIZZA INDIA LTD.)
LOGIX TECHNO PARK, PLOT NO. 5,
TOWER - D, 5th FLOOR,
SECTOR - 127, NOIDA-201304.
PHONE: 0120-4090500, 4090594.

THESE PLANS & SPECIFICATIONS AS WELL AS DOMINO'S
NAME & LOGO, TRADEMARKS & DESIGNS ARE THE EXCLUSIVE
PROPERTY OF JUBILANT COMPANY. ANY REPRODUCTION,
MODIFICATION, DISCLOSURE AND/OR USE OF THESE
MATERIALS (OR BY PORTION OF THEM) WITHOUT DOMINO'S
PRIOR WRITTEN CONSENT IS STRICTLY PROHIBITED.

DISCLAIMER-
IN CASE OF ANY SITE DISCREPANCY,
PLEASE GET BACK TO CORPORATE
DESIGN TEAM

JUBILANT FOODWORKS
INDIA LTD.

PROJ : GMR 1D DELHI
TOTAL AREA : 670 SQFT
KITCHEN AREA : 502 SQFT
BOH AREA : 178 SQFT
ZONE : NORTH
COUNTRY : INDIA.


RESTAURANT NO.:


DRAWN BY : VARUN
CHECKED BY :
ISSUED ON : 26-09-2023

REVISION NO.	REVISION DATE
1	11-10-2023
2	20-10-2023
3	27-10-2023
4	-2022

REMARKS : REVISED AS COMMENT
SCALE : NOT TO SCALE.
SHEET NO. : 6
SHEET TITLE : CEILING PLAN

LEGEND				
SYMBOL	REF. IMAGES	QTY.	ARTICLE NO.	PRODUCT-DESCRIPTION
			13	36 W PROFILE LIGHT FOR KITCHEN IN 6000 K KELVIN-40 WATTS- WITH 3 PCB ROWS/REQ. LENGTH OF 1.2 METRS IN SIZE OF 65X65MM OR 70X70MM/MIN MULTIPLES OF 8"12"16" IN 10W/RF.T. FINISHED WITH BLACK POWDER COATING
			01	AIR CURTAIN AS PER APPROVED INOS.
			00	SPLIT UNIT
			05	NORMAL T5 LIGHT
			10	DECO.PENDANT LIGHT FOR KITCHEN IN 6000KELVIN LED BULB OF 6 WATTS IN 3"-4"HT. WITH B22 HOLDER,INDOOR FIXTURE
			E	EMERGENCY LIGHT
			00	4-WAY CASSETTE UNIT
			5895	STRIP LIGHT IN COUNTER (4430+1465 = 5895MM)

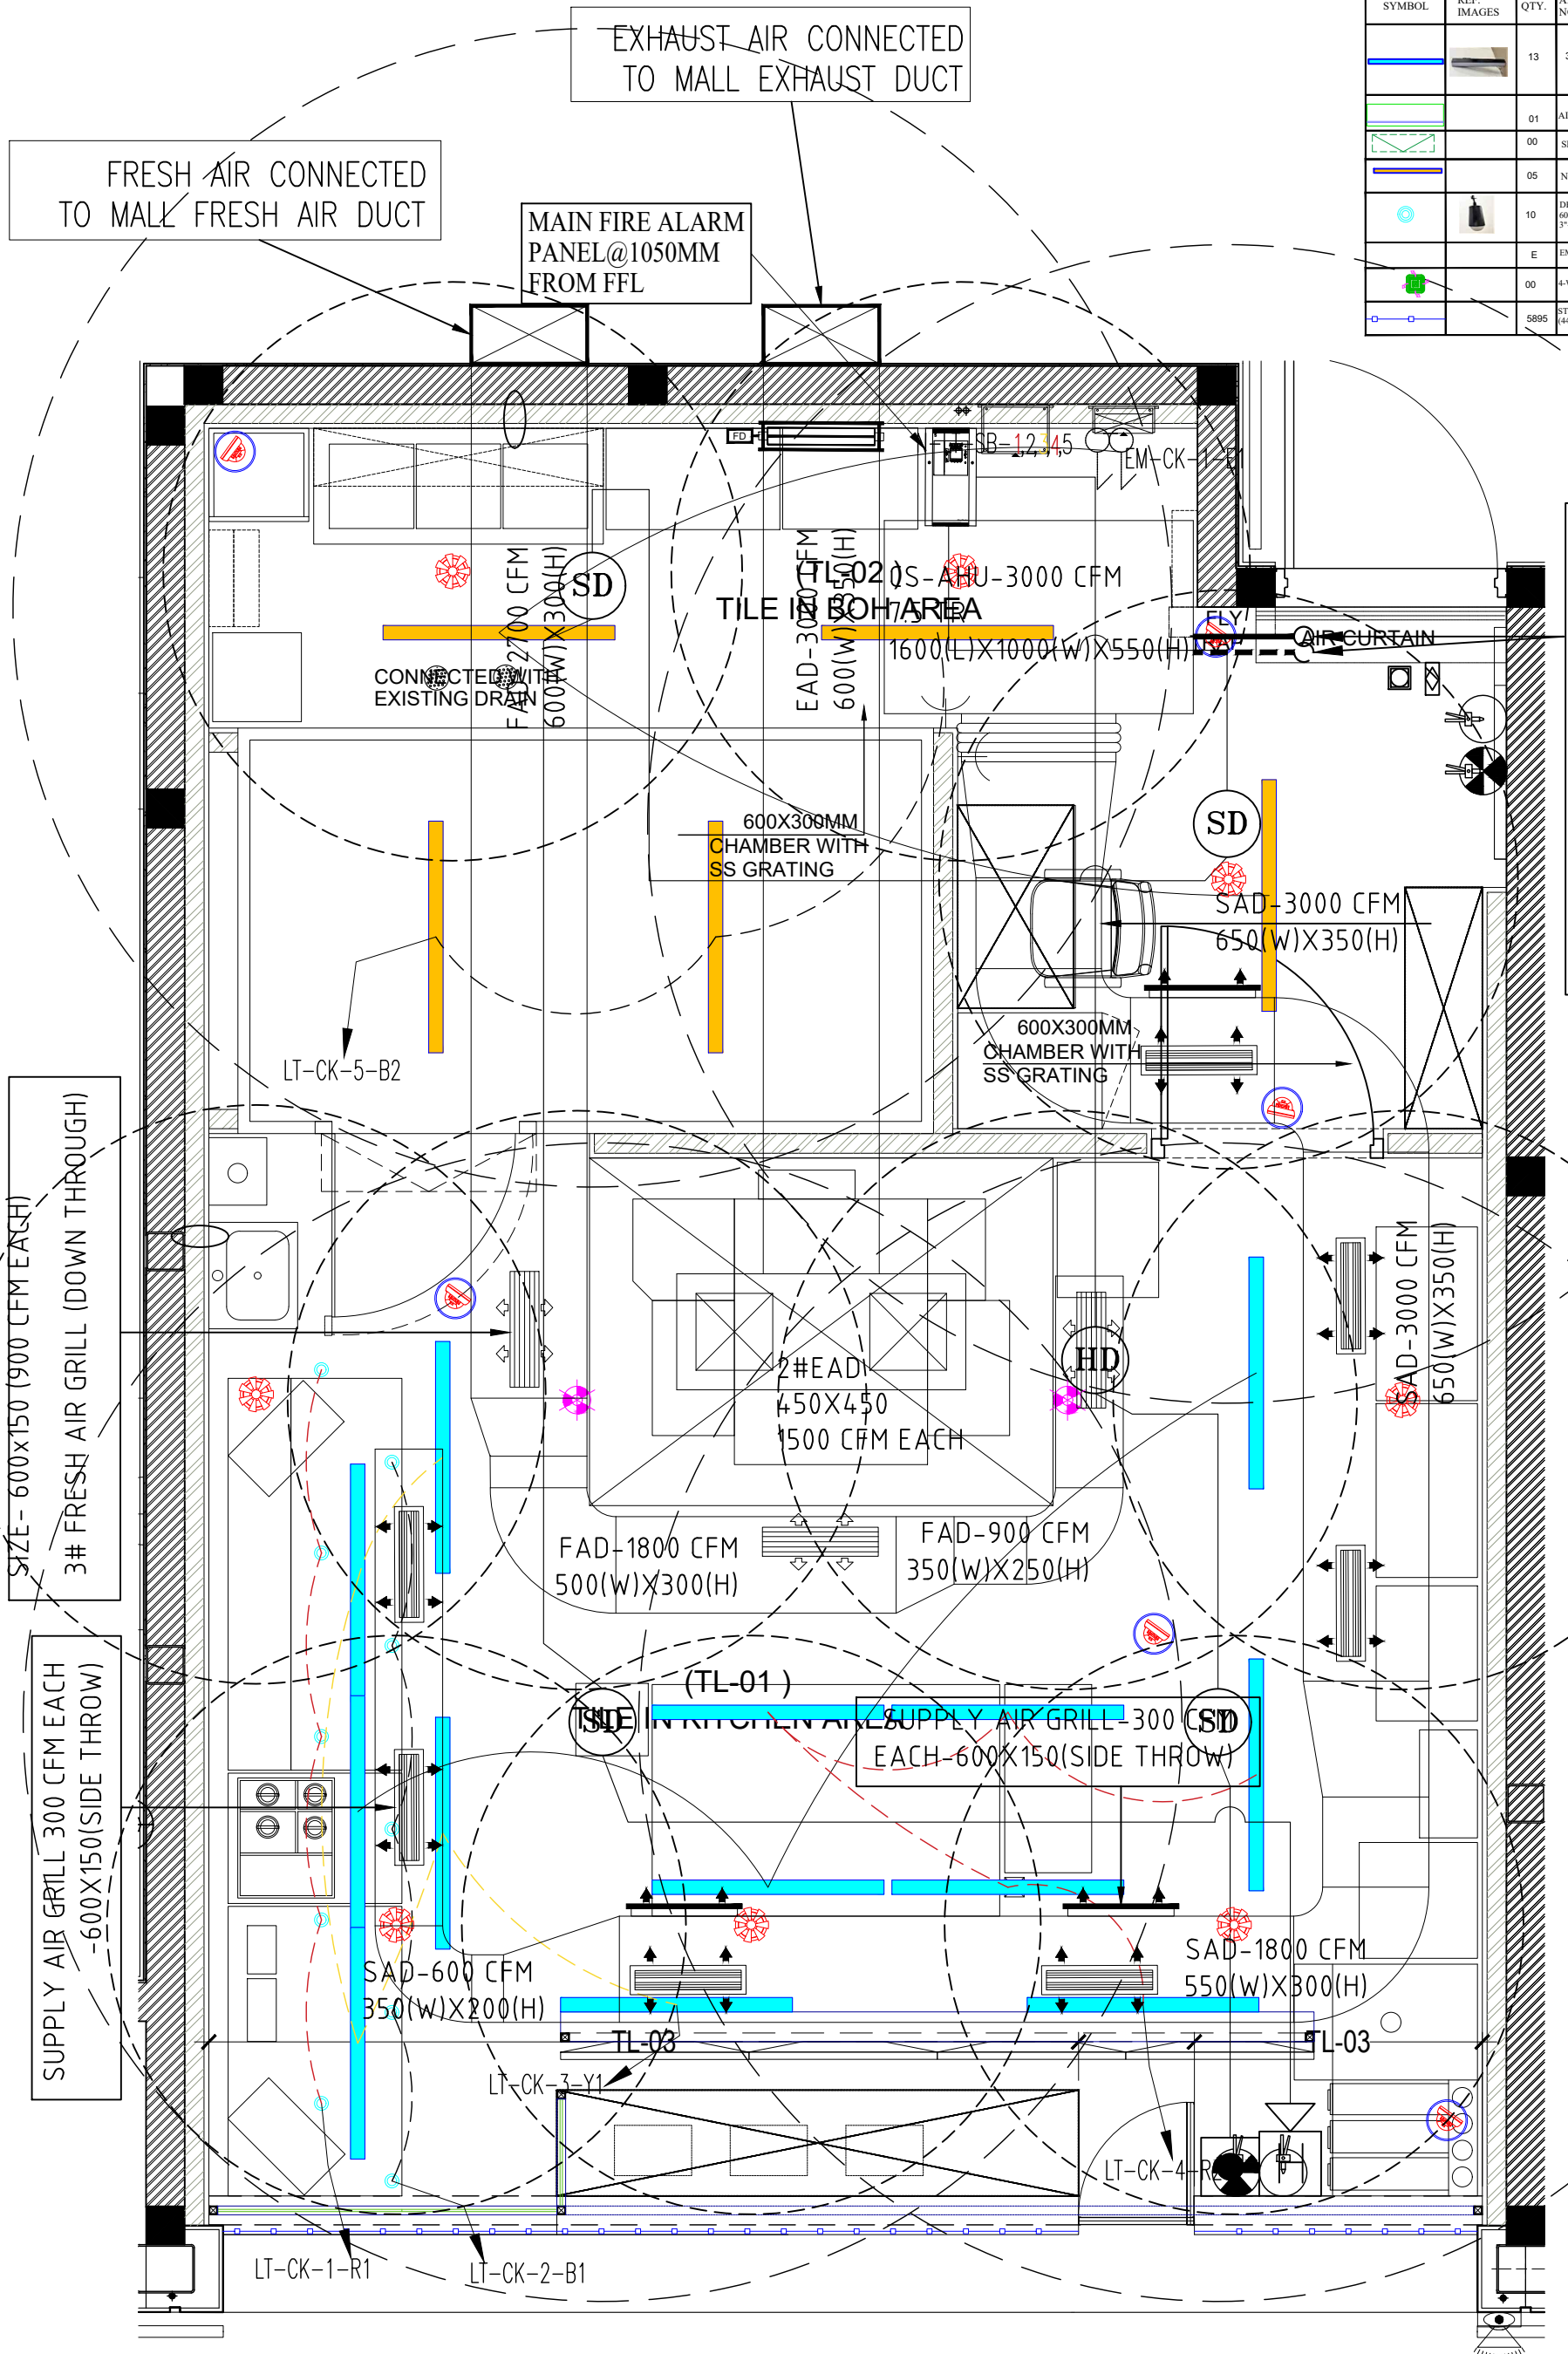



**Domino's
Pizza**

JUBILANT FOODWORKS LTD.
(DOMINO'S PIZZA INDIA LTD.)
LOGIX TECHNO PARK, PLOT NO. 5,
TOWER - D, 5th FLOOR,
SECTOR - 127, NOIDA-201304,
PHONE: 0120-4090500, 4090594.

THESE PLANS & SPECIFICATIONS AS WELL AS DOMINO'S NAME & LOGO, TRADEMARKS & DESIGNS ARE THE EXCLUSIVE PROPERTY OF JUBILANT COMPANY. ANY REPRODUCTION, MODIFICATION, DISCLOSURE AND/OR USE OF THESE MATERIALS (OR BY PORTION OF THEM) WITHOUT DOMINO'S PRIOR WRITTEN CONSENT IS STRICTLY PROHIBITED.

DISCLAIMER-
IN CASE OF ANY SITE DISCREPANCY,
PLEASE GET BACK TO CORPORATE
DESIGN TEAM

JUBILANT FOODWORKS
INDIA LTD.

PROJ : GMR 1D DELHI
TOTAL AREA : 670 SQFT
KITCHEN AREA : 502 SQFT
BOH AREA : 178 SQFT
ZONE : NORTH
COUNTRY : INDIA.


RESTAURANT NO.:


DRAWN BY : VARUN
CHECKED BY :
ISSUED ON : 26-09-2023

REVISION NO.	REVISION DATE
1	11-10-2023
2	20-10-2023
3	27-10-2023
4	-2022

REMARKS : REVISED AS/COMMENT
SCALE : NOT TO SCALE.
SHEET NO. : 7
SHEET TITLE : RCP PLAN

LEGEND				
SYMBOL	REF. IMAGES	QTY.	ARTICLE NO.	PRODUCT- DESCRIPTION
			13	36 W PROFILE LIGHT FOR KITCHEN IN 6000 KELVIN-40 WATTS- WITH 3 PCB ROWS/REQ. LENGTH OF 1.2 MTRS IN SIZE OF 6565MM OR 70X70MM IN MULTIPLES OF 8'12'16" IN 10W/REF. FINISHED WITH BLACK POWDER COATING.
			01	AIR CURTAIN AS PER APPROVED INOS.
			00	SPLIT UNIT
			05	NORMAL T5 LIGHT
			10	DECO.PENDANT LIGHT FOR KITCHEN IN 6000KELVIN LED BULB OF 6 WATTS IN 3'-4"FIT. WITH B22 HOLDER INDOOR FIXTURE
			E	EMERGENCY LIGHT
			00	4-WAY CASSETTE UNIT
			5895	STRIP LIGHT IN COUNTER (4430+1465 = 5895MM)

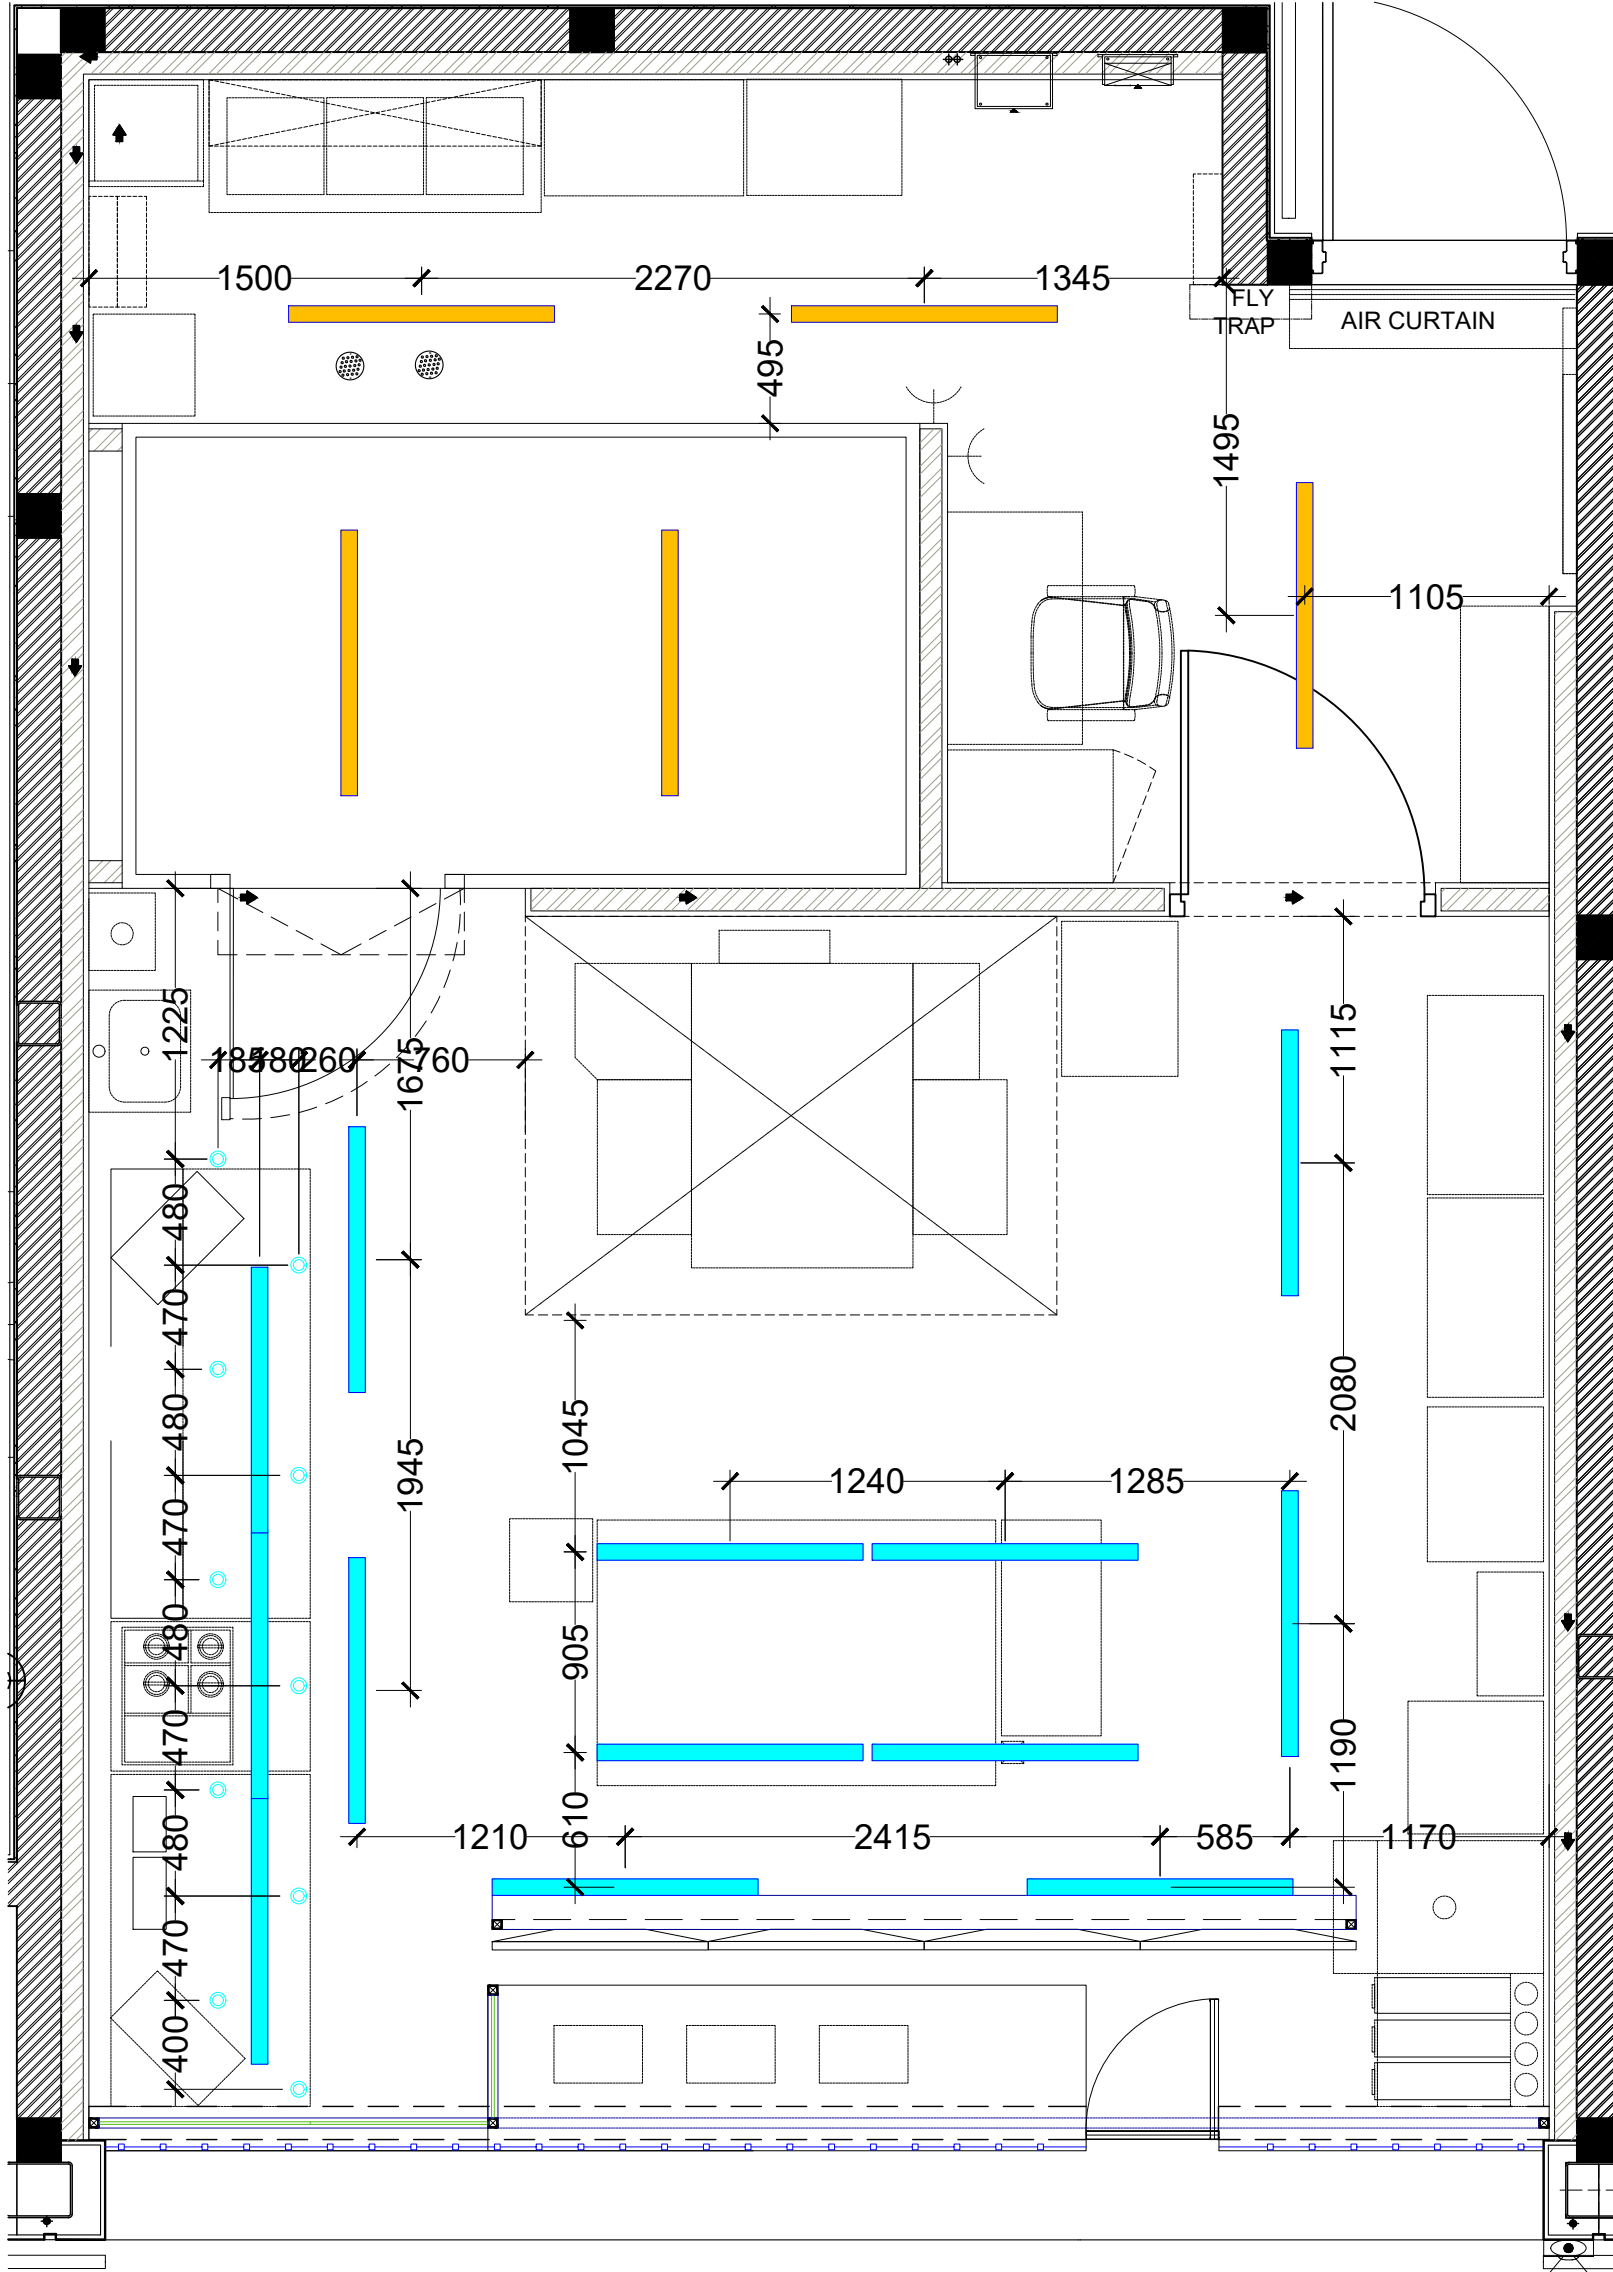



**Domino's
Pizza**

JUBILANT FOODWORKS LTD.
(DOMINO'S PIZZA INDIA LTD.)
LOGIX TECHNO PARK, PLOT NO. 5,
TOWER - D, 5th FLOOR,
SECTOR - 127, NOIDA-201304,
PHONE: 0120-4090500, 4090594.

THESE PLANS & SPECIFICATIONS AS WELL AS DOMINO'S NAME & LOGO, TRADEMARKS & DESIGNS ARE THE EXCLUSIVE PROPERTY OF JUBILANT COMPANY. ANY REPRODUCTION, MODIFICATION, DISCLOSURE AND/OR USE OF THESE MATERIALS FOR BY PORTION OF THEM/WITHOUT DOMINO'S PRIOR WRITTEN CONSENT IS STRICTLY PROHIBITED.

DISCLAIMER-
IN CASE OF ANY SITE DISCREPANCY,
PLEASE GET BACK TO CORPORATE
DESIGN TEAM

JUBILANT FOODWORKS
INDIA LTD.

PROJ : GMR 1D DELHI
TOTAL AREA : 670 SQFT
KITCHEN AREA : 502 SQFT
BOH AREA : 178 SQFT
ZONE : NORTH
COUNTRY : INDIA.


RESTAURANT NO.:


DRAWN BY : VARUN
CHECKED BY :
ISSUED ON : 26-09-2023

REVISION NO.	REVISION DATE
1	11-10-2023
2	20-10-2023
3	27-10-2023
4	-2022

REMARKS : REVISED AS/COMMENT
SCALE : NOT TO SCALE.
SHEET NO. : 8
SHEET TITLE : LIGHTING PLAN

LEGEND				
SYMBOL	REF. IMAGES	QTY.	ARTICLE NO.	PRODUCT- DESCRIPTION
		05		CCTV CAMERA

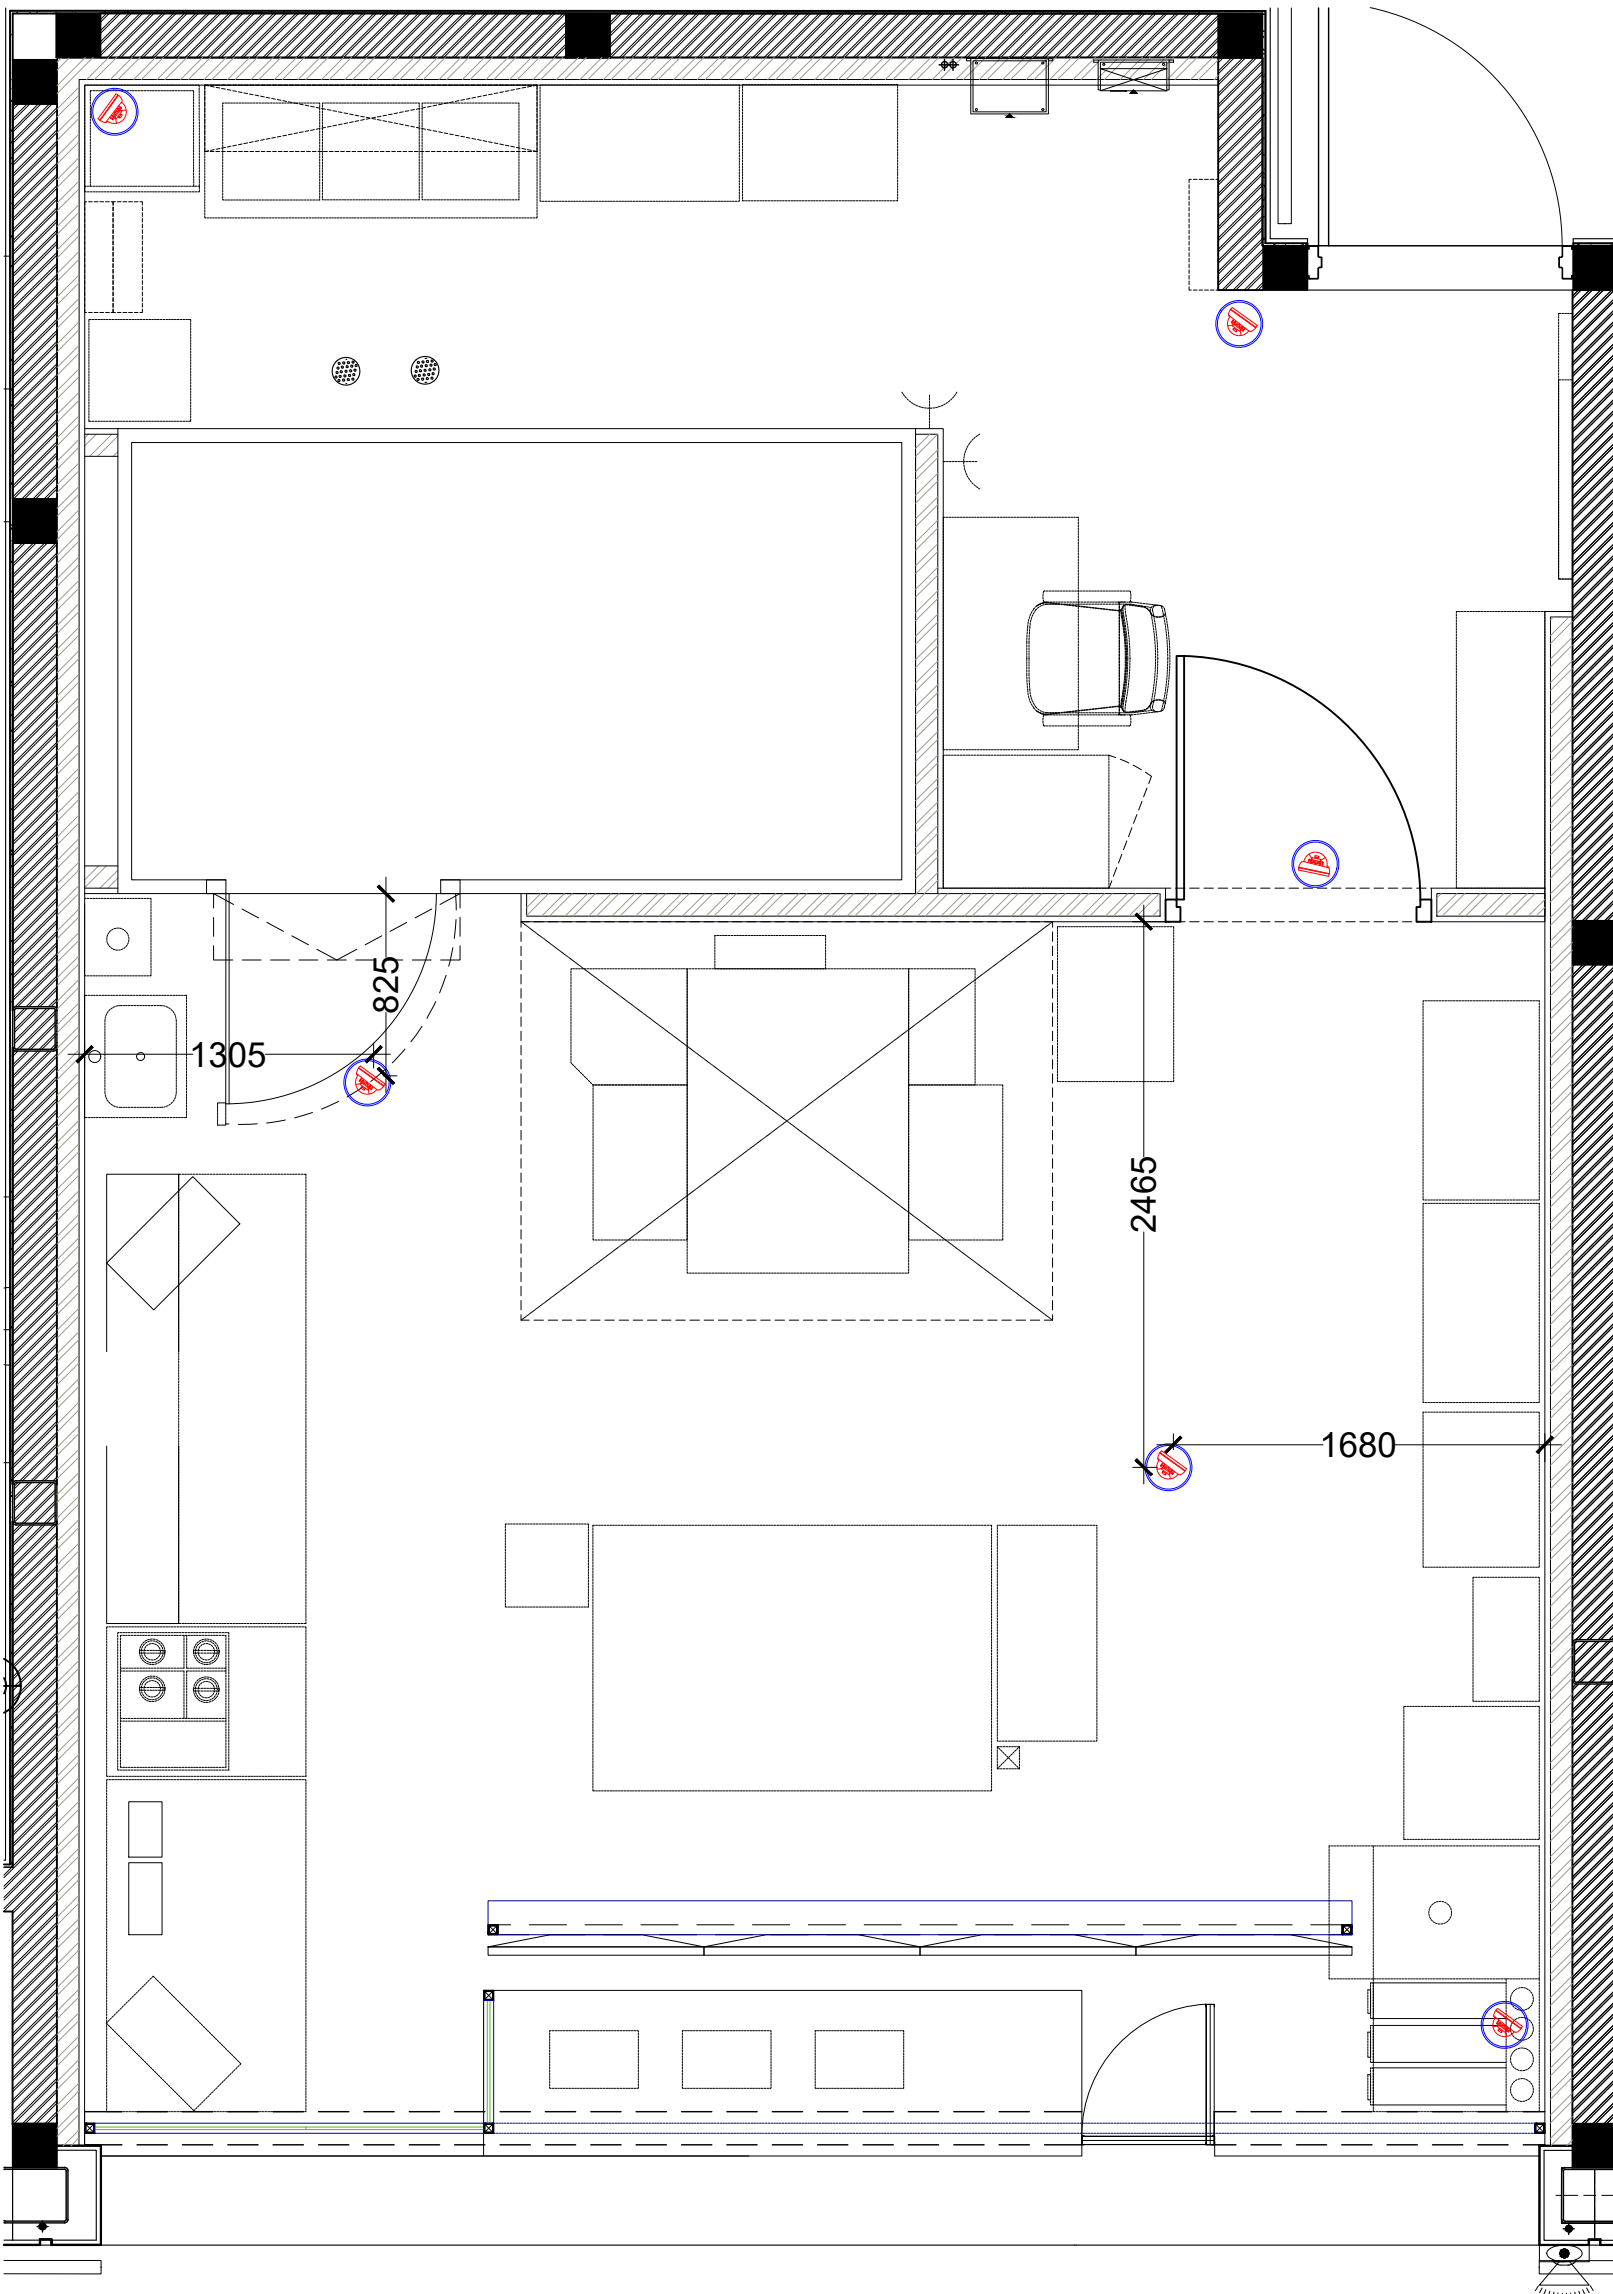

 

**Domino's
Pizza**

JUBILANT FOODWORKS LTD.
(DOMINO'S PIZZA INDIA LTD.)
LOGIX TECHNO PARK, PLOT NO. 5,
TOWER - D, 5th FLOOR,
SECTOR - 127, NOIDA-201304.
PHONE: 0120-4090500, 4090594.

THESE PLANS & SPECIFICATIONS AS WELL AS DOMINO'S NAME & LOGO, TRADEMARKS & DESIGNS ARE THE EXCLUSIVE PROPERTY OF JUBILANT COMPANY. ANY REPRODUCTION, MODIFICATION, DISCLOSURE AND/OR USE OF THESE MATERIALS (OR BY PORTION OF THEM) WITHOUT DOMINO'S PRIOR WRITTEN CONSENT IS STRICTLY PROHIBITED.

DISCLAIMER-
IN CASE OF ANY SITE DISCREPANCY,
PLEASE GET BACK TO CORPORATE
DESIGN TEAM

JUBILANT FOODWORKS
INDIA LTD.

PROJ : GMR 1D DELHI
TOTAL AREA : 670 SQFT
KITCHEN AREA : 502 SQFT
BOH AREA : 178 SQFT
ZONE : NORTH
COUNTRY : INDIA.

RESTAURANT NO.:


DRAWN BY : VARUN
CHECKED BY :
ISSUED ON : 26-09-2023

REVISION NO.	REVISION DATE
1	11-10-2023
2	20-10-2023
3	27-10-2023
4	-2022

REMARKS : REVISED AS COMMENT
SCALE : NOT TO SCALE
SHEET NO. : 10
SHEET TITLE : CAMERA PLAN

HVAC LEGEND:-

SYMBOL	DESCRIPTION
	FRESH AIR RECTANGULAR DUCT
	EXHAUST AIR RECTANGULAR DUCT
	SUPPLY AIR RECTANGULAR DUCT
	FRESH AIR GRILLE-600X150
	FIRE DAMPER
	SUPPLY AIR HORIZONTAL GRILLE
	SUPPLY AIR VERTICAL GRILLE
	VOLUME CONTRIL DAMPER(VCD)
	CS-AHU 7.5TR(3000 CFM)

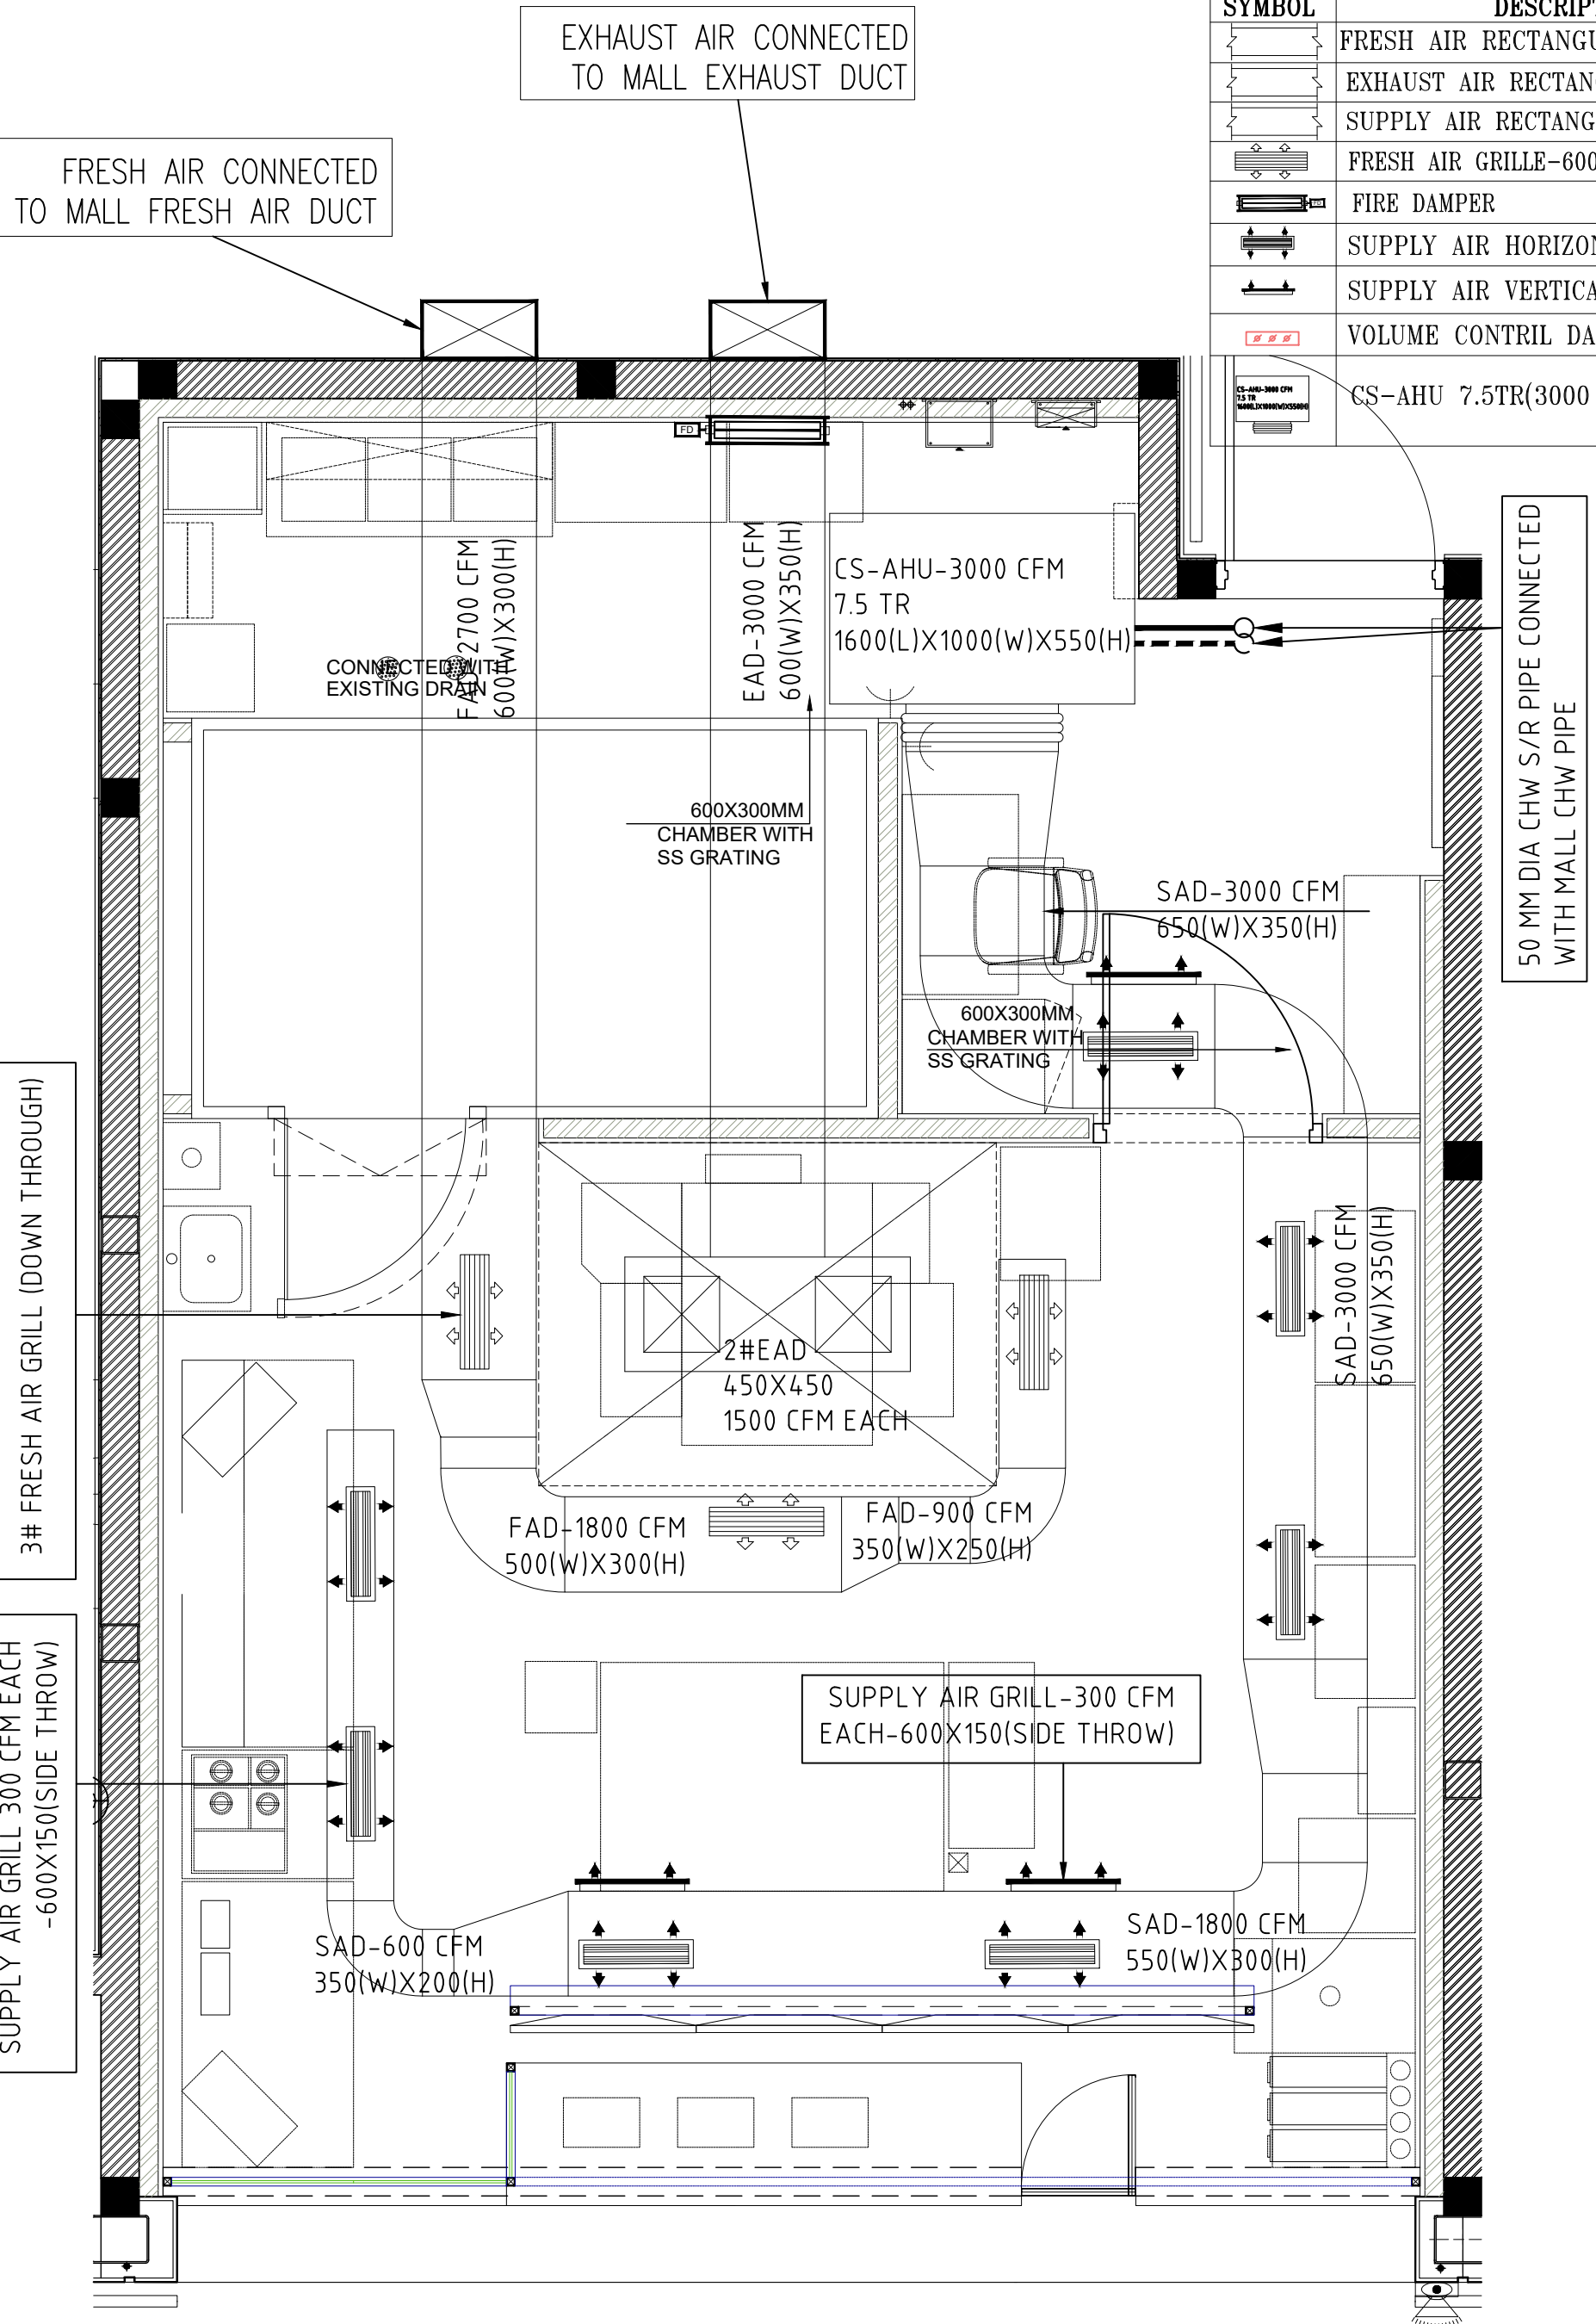

Domino's Pizza

JUBILANT FOODWORKS LTD.
 (DOMINO'S PIZZA INDIA LTD.)
 LOGIX TECHNO PARK, PLOT NO. 5,
 TOWER - D, 5th FLOOR,
 SECTOR - 127, NOIDA-201304.
 PHONE: 0120-4090500, 4090594.

THESE PLANS & SPECIFICATIONS AS WELL AS DOMINO'S NAME & LOGO, TRADEMARKS & DESIGNS ARE THE EXCLUSIVE PROPERTY OF JUBILANT COMPANY. ANY REPRODUCTION, MODIFICATION, DISCLOSURE AND/OR USE OF THESE MATERIALS FOR BY PORTION OF THEM WITHOUT DOMINO'S PRIOR WRITTEN CONSENT IS STRICTLY PROHIBITED.

DISCLAIMER-
 IN CASE OF ANY SITE DISCREPANCY, PLEASE GET BACK TO CORPORATE DESIGN TEAM

JUBILANT FOODWORKS INDIA LTD.

PROJ : GMR 1D DELHI
 TOTAL AREA : 670 SQFT
 KITCHEN AREA : 502 SQFT
 BOH AREA : 178 SQFT
 ZONE : NORTH
 COUNTRY : INDIA.


RESTAURANT NO.:

DRAWN BY : VARUN
 CHECKED BY :
 ISSUED ON : 26-09-2023

REVISION NO.	REVISION DATE
1	11-10-2023
2	20-10-2023
3	27-10-2023
4	-2022

REMARKS : REVISED AS COMMENT
 SCALE : NOT TO SCALE.
 SHEET NO. : 11
 SHEET TITLE : AC PLAN

FIRE EXTINGUISHER LEGEND	
SYMBOL	DESCRIPTION
	FIRE EXTINGUISHER - ABC - 6.0 KG
	FIRE EXTINGUISHER - CO2 - 4.5 KG
	68 °C PENDENT SPRINKLER
	79 °C PENDENT SPRINKLER
	SPRINKLER PIPE
	BUTTERFLY VALVE

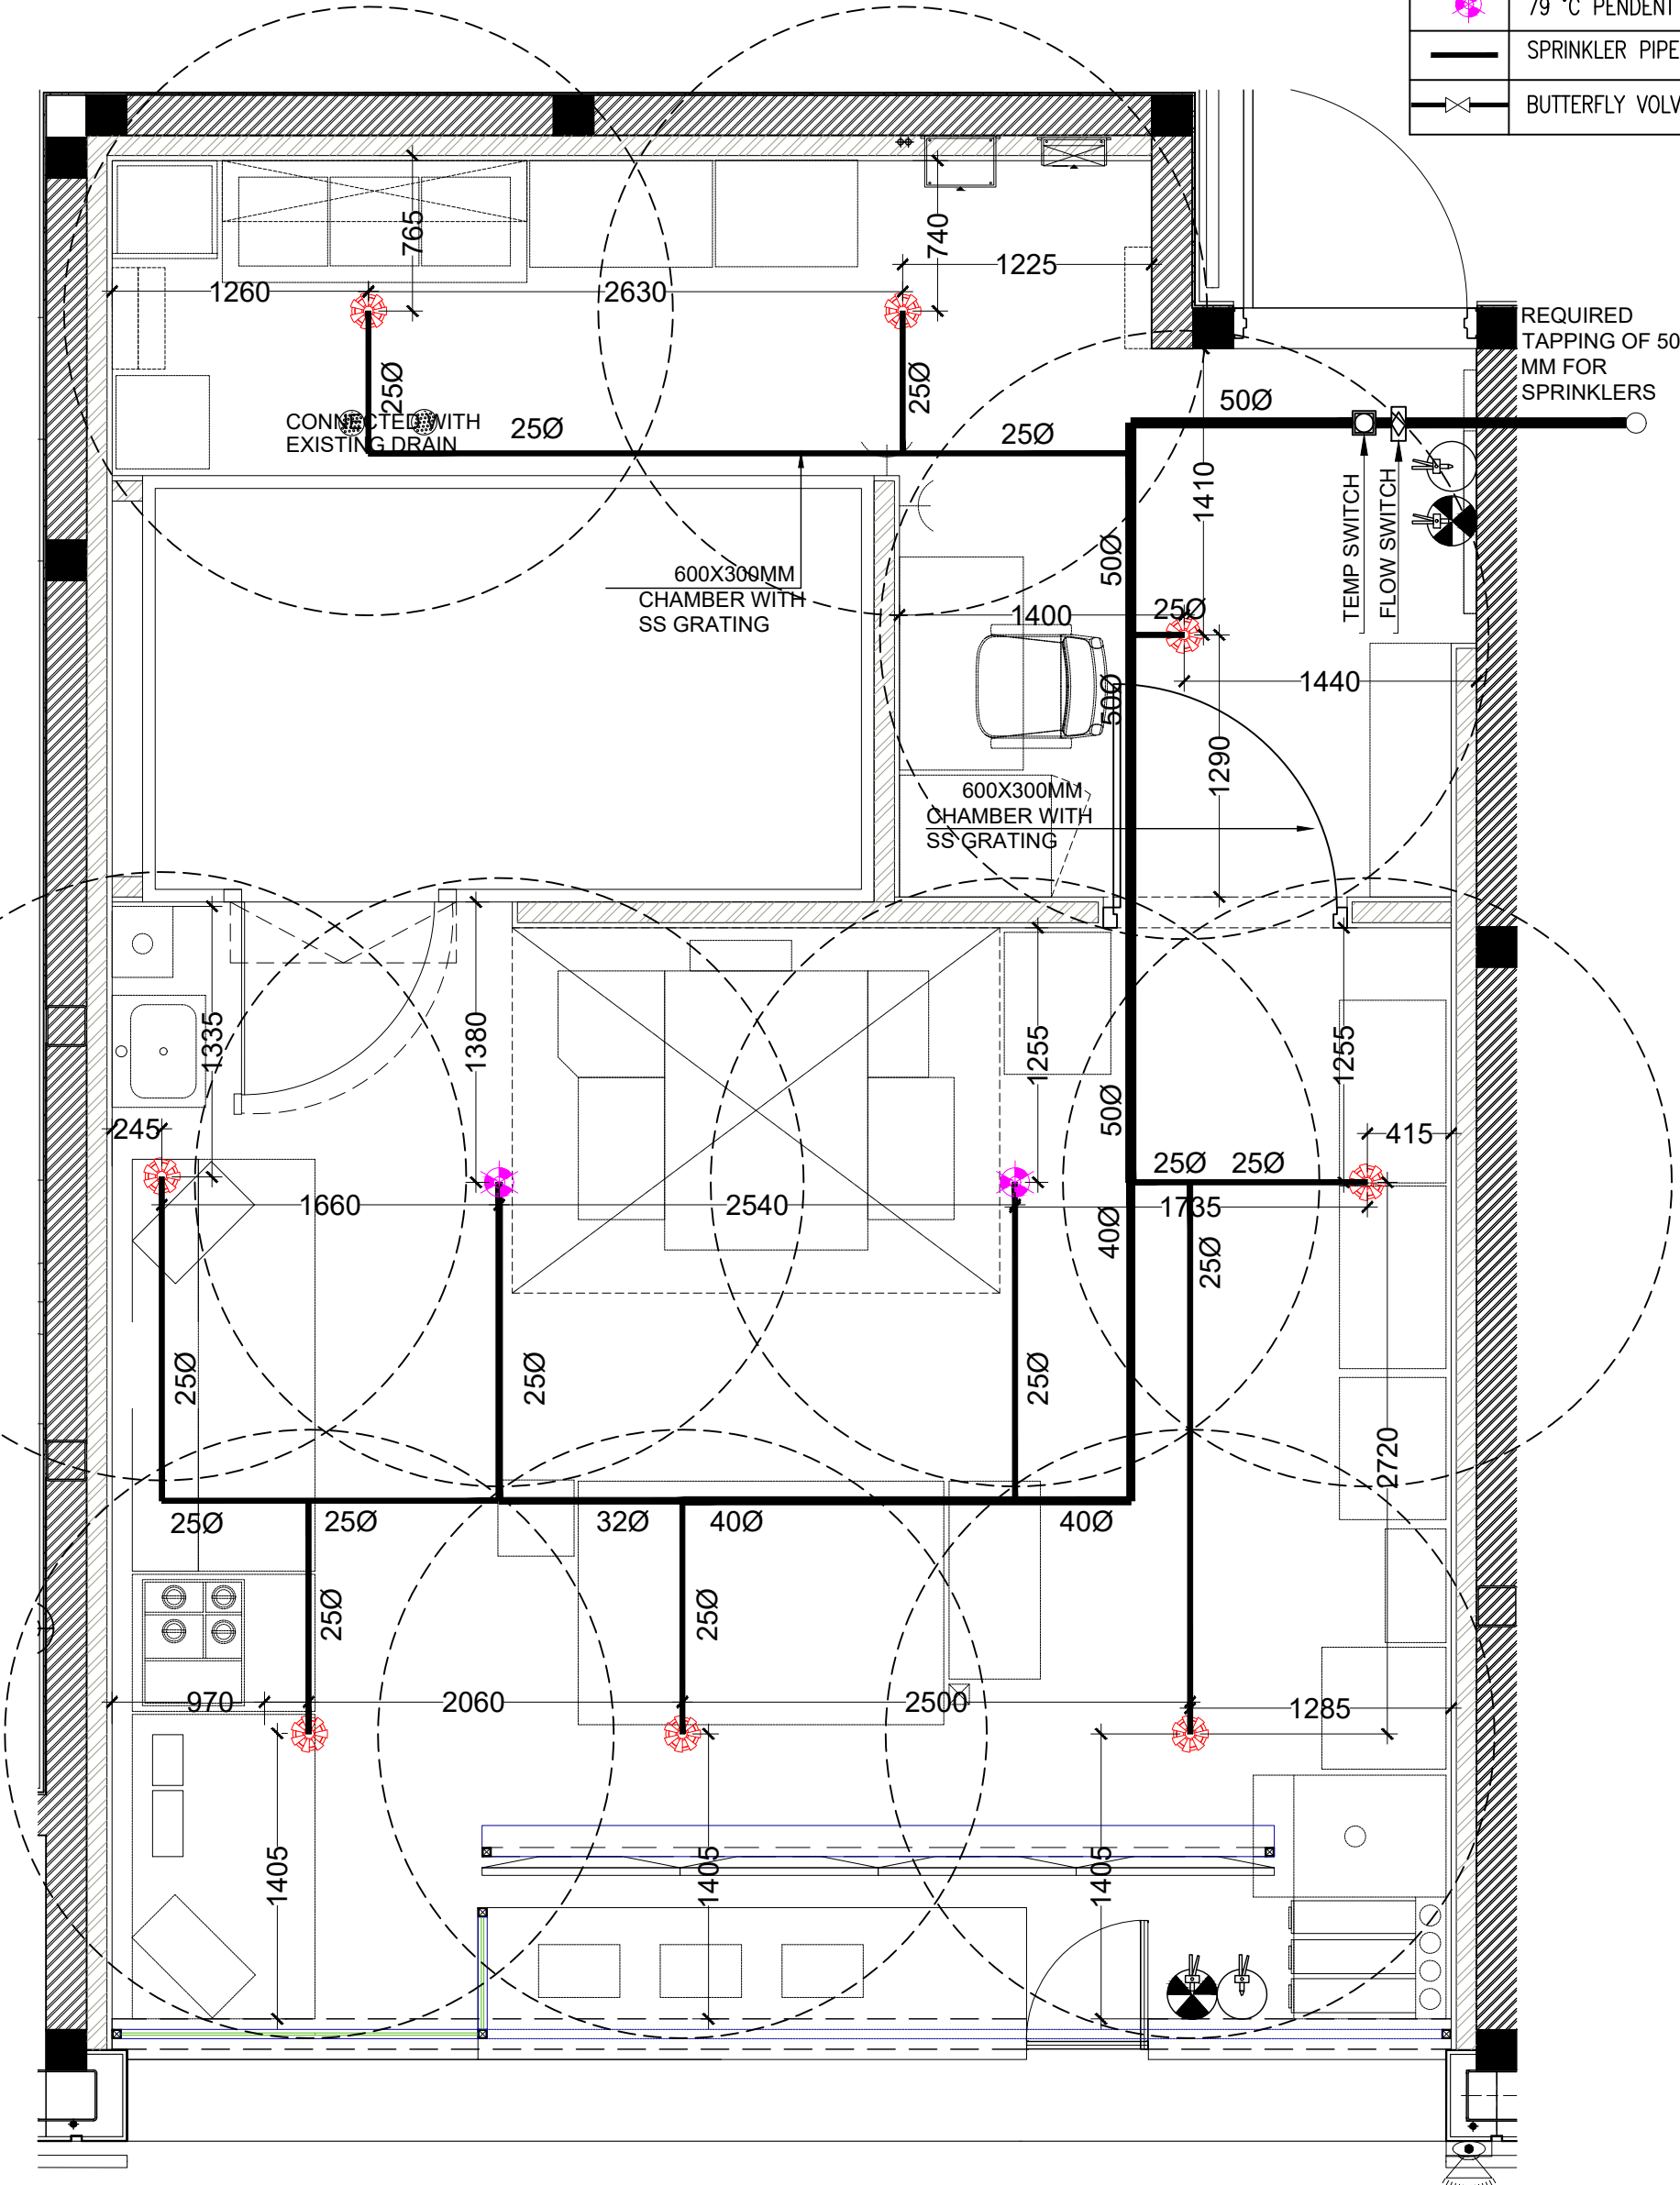


REQUIRED TAPPING OF 50 MM FOR SPRINKLERS

CONNECTED WITH EXISTING DRAIN

600X300MM CHAMBER WITH SS GRATING

600X300MM CHAMBER WITH SS GRATING

 TEMP SWITCH
FLOW SWITCH



**Domino's
Pizza**

JUBILANT FOODWORKS LTD.
(DOMINO'S PIZZA INDIA LTD.)
LOGIX TECHNO PARK, PLOT NO. 5,
TOWER - D, 5th FLOOR,
SECTOR - 127, NOIDA-201304,
PHONE: 0120-4090500, 4090594.

THESE PLANS & SPECIFICATIONS AS WELL AS DOMINO'S NAME & LOGO, TRADEMARKS & DESIGNS ARE THE EXCLUSIVE PROPERTY OF JUBILANT COMPANY. ANY REPRODUCTION, MODIFICATION, DISCLOSURE AND/OR USE OF THESE MATERIALS (OR BY PORTION OF THEM) WITHOUT DOMINO'S PRIOR WRITTEN CONSENT IS STRICTLY PROHIBITED.

DISCLAIMER-
IN CASE OF ANY SITE DISCREPANCY,
PLEASE GET BACK TO CORPORATE
DESIGN TEAM

JUBILANT FOODWORKS
INDIA LTD.

 




PROJ : GMR 1D DELHI
TOTAL AREA : 670 SQFT
KITCHEN AREA : 502 SQFT
BOH AREA : 178 SQFT
ZONE : NORTH
COUNTRY : INDIA.

RESTAURANT NO.:


DRAWN BY : VARUN
CHECKED BY :
ISSUED ON : 26-09-2023


REVISION NO.	REVISION DATE
1	11-10-2023
2	20-10-2023
3	27-10-2023
4	-2022

REMARKS : REVISED AS COMMENT
SCALE : NOT TO SCALE.
SHEET NO. : 12
SHEET TITLE : FIRE PLAN

Item Description	
	2 RUNS OF 1.5 SQ.MM, PVC INSULATED COPPERS IN PVC FRLS ARMOUDERD CABLE FIRE ALARM DEVICES
	FIRE ALARM PANEL
	SMOKE DETECTOR
	MANUAL CALL POINT
	HOOTER
	HEAT DETECTOR

 MAIN FIRE ALARM PANEL@1050MM FROM FFL

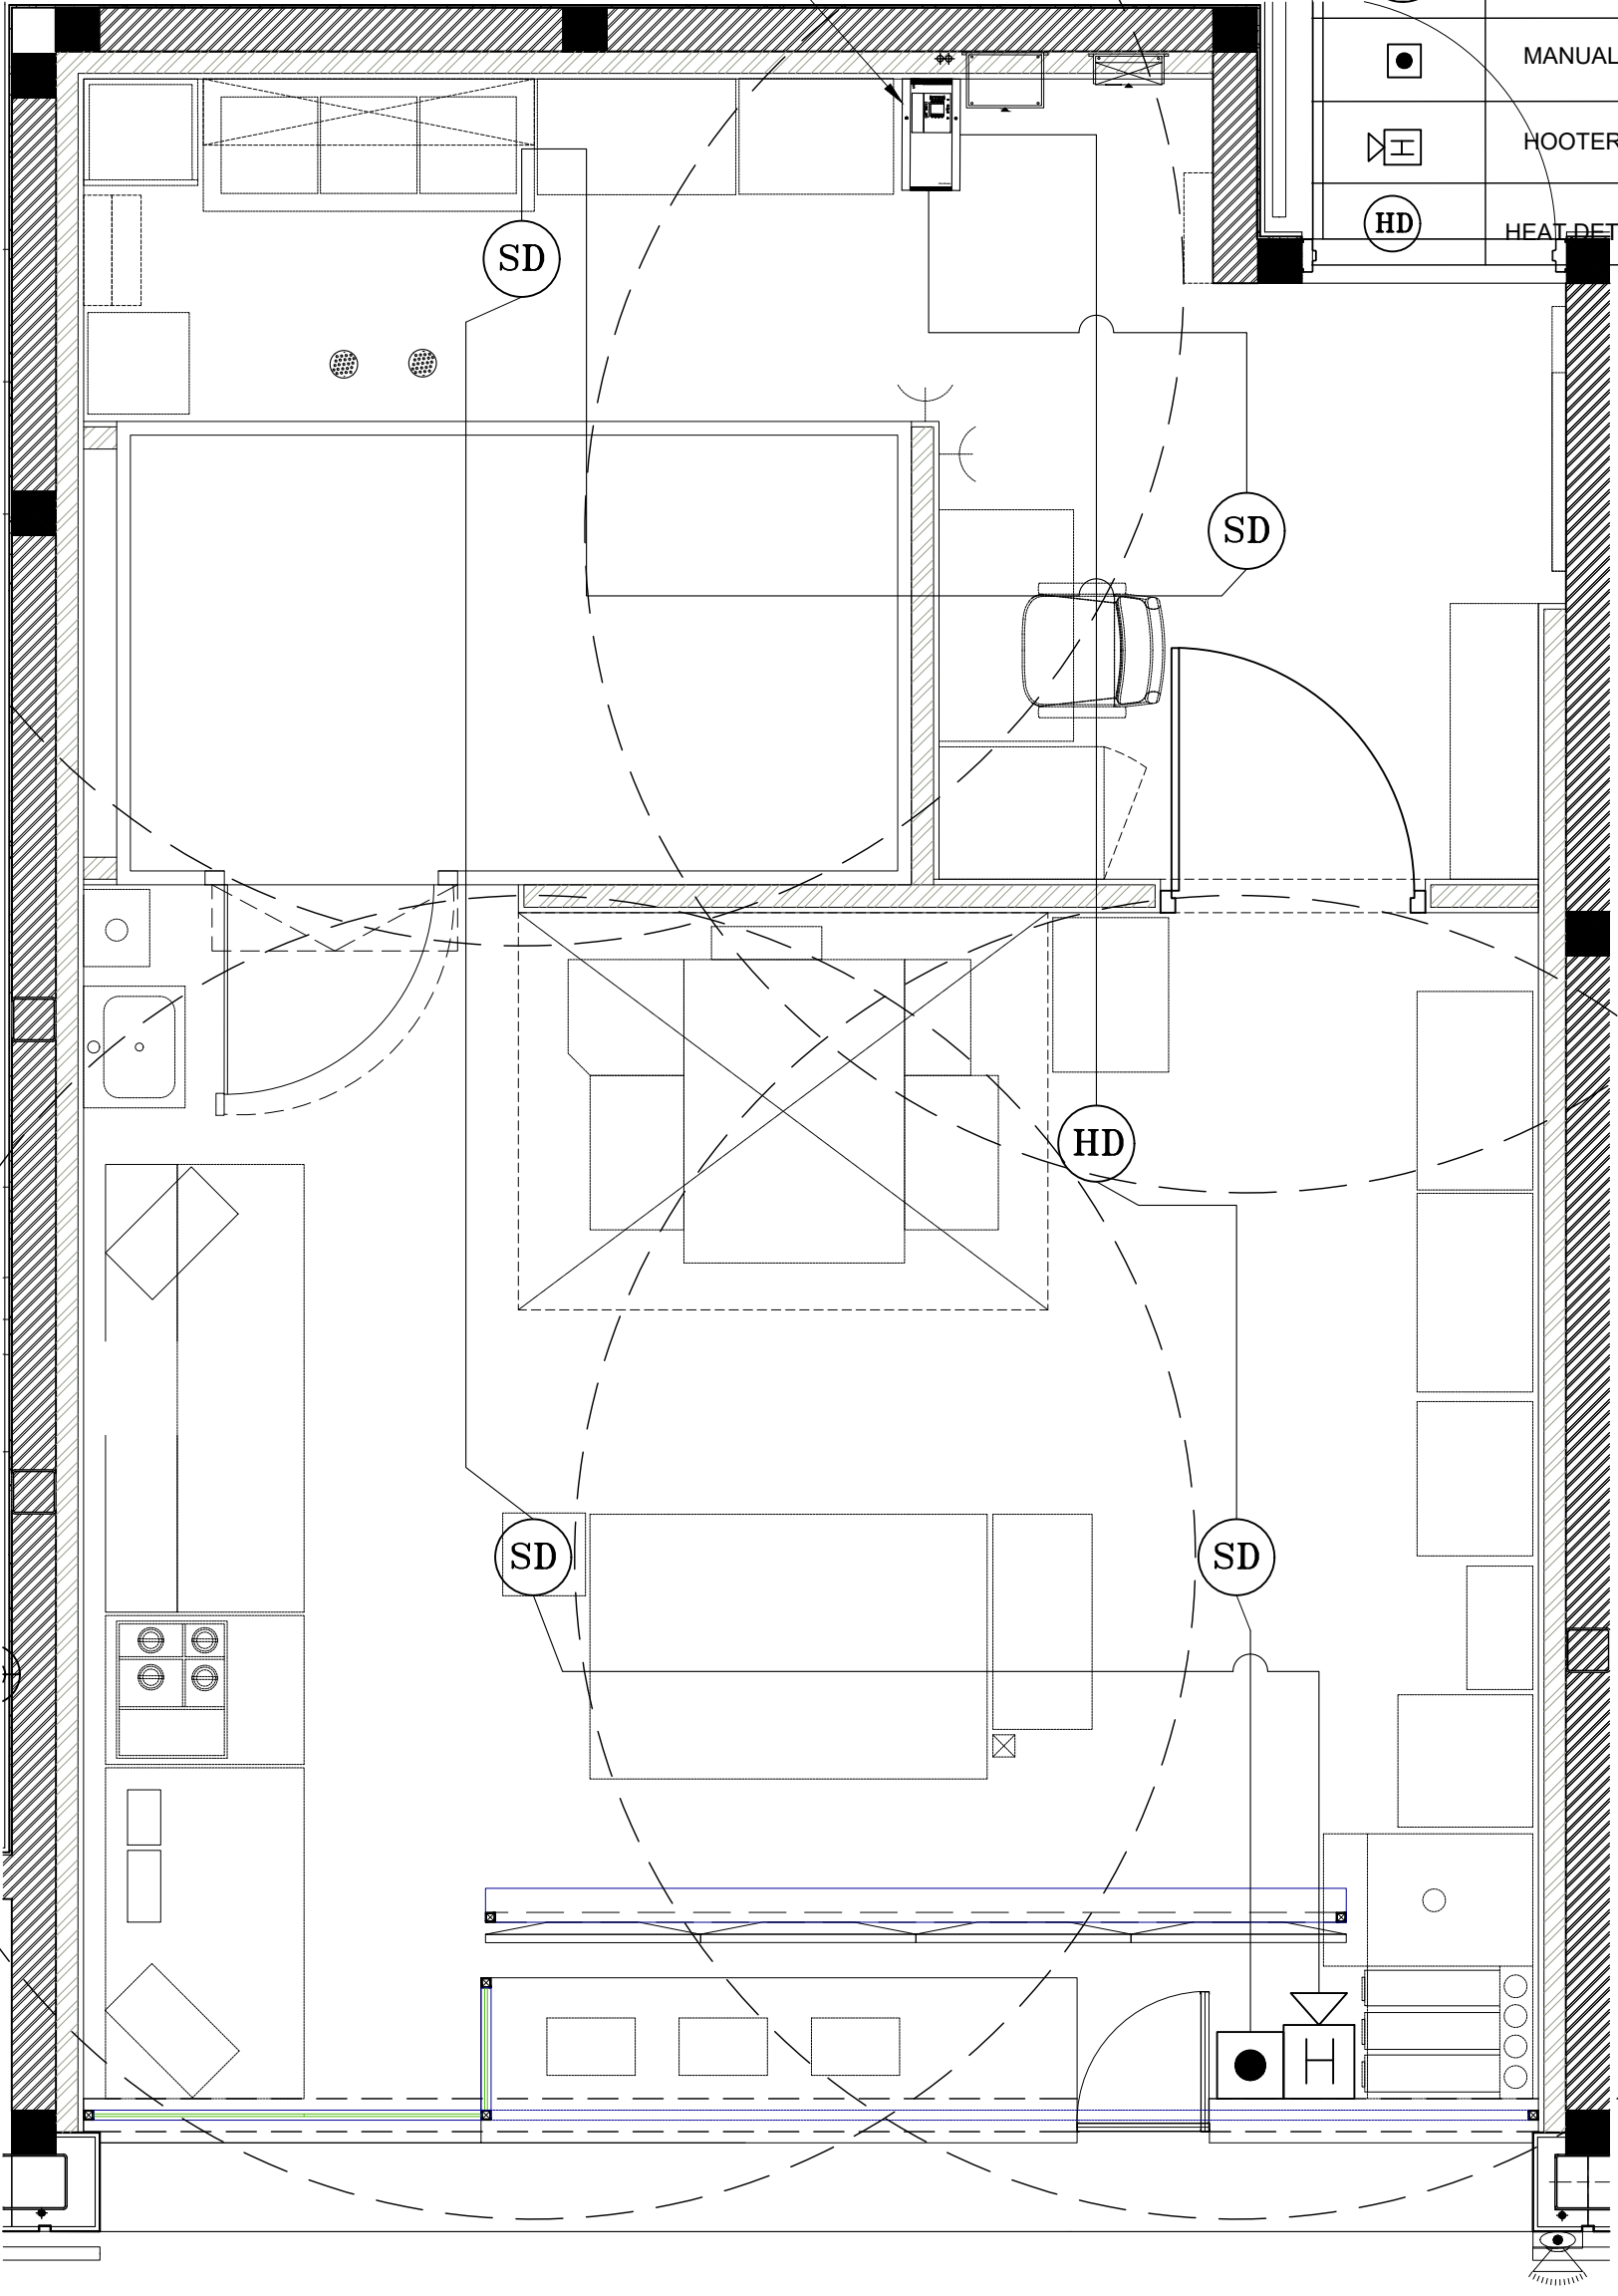



**Domino's
Pizza**

JUBILANT FOODWORKS LTD.
(DOMINO'S PIZZA INDIA LTD.)
LOGIX TECHNO PARK, PLOT NO. 5,
TOWER - D, 5th FLOOR,
SECTOR - 127, NOIDA-201304.
PHONE: 0120-4090500, 4090594.

THESE PLANS & SPECIFICATIONS AS WELL AS DOMINO'S NAME & LOGO, TRADEMARKS & DESIGNS ARE THE EXCLUSIVE PROPERTY OF JUBILANT COMPANY. ANY REPRODUCTION, MODIFICATION, DISCLOSURE AND/OR USE OF THESE MATERIALS OR BY PORTION OF THEM WITHOUT DOMINO'S PRIOR WRITTEN CONSENT IS STRICTLY PROHIBITED.

DISCLAIMER-
IN CASE OF ANY SITE DISCREPANCY,
PLEASE GET BACK TO CORPORATE
DESIGN TEAM

JUBILANT FOODWORKS
INDIA LTD.

PROJ : GMR 1D DELHI
TOTAL AREA : 670 SQFT
KITCHEN AREA : 502 SQFT
BOH AREA : 178 SQFT
ZONE : NORTH
COUNTRY : INDIA.

RESTAURANT NO.:



DRAWN BY : VARUN
CHECKED BY :
ISSUED ON : 26-09-2023

REVISION NO.	REVISION DATE
1	11-10-2023
2	20-10-2023
3	27-10-2023
4	-2022

REMARKS : REVISED AS COMMENT
SCALE : NOT TO SCALE.
SHEET NO. : 13
SHEET TITLE : SD PLAN

DRAINAGE LEGENDS

S.NO.	DESCRIPTION	LEGEND
1	FLOOR TRAP	⊗ FT
2	FLOOR DRAIN	⊙ FD
3	WATER DIRECTION	→
4	KITCHEN WASTE PIPE (UPVC)	≡≡≡
5	600X300MM CHAMBER WITH SS GRATING	
6	PORTABLE GREASE TRAP	

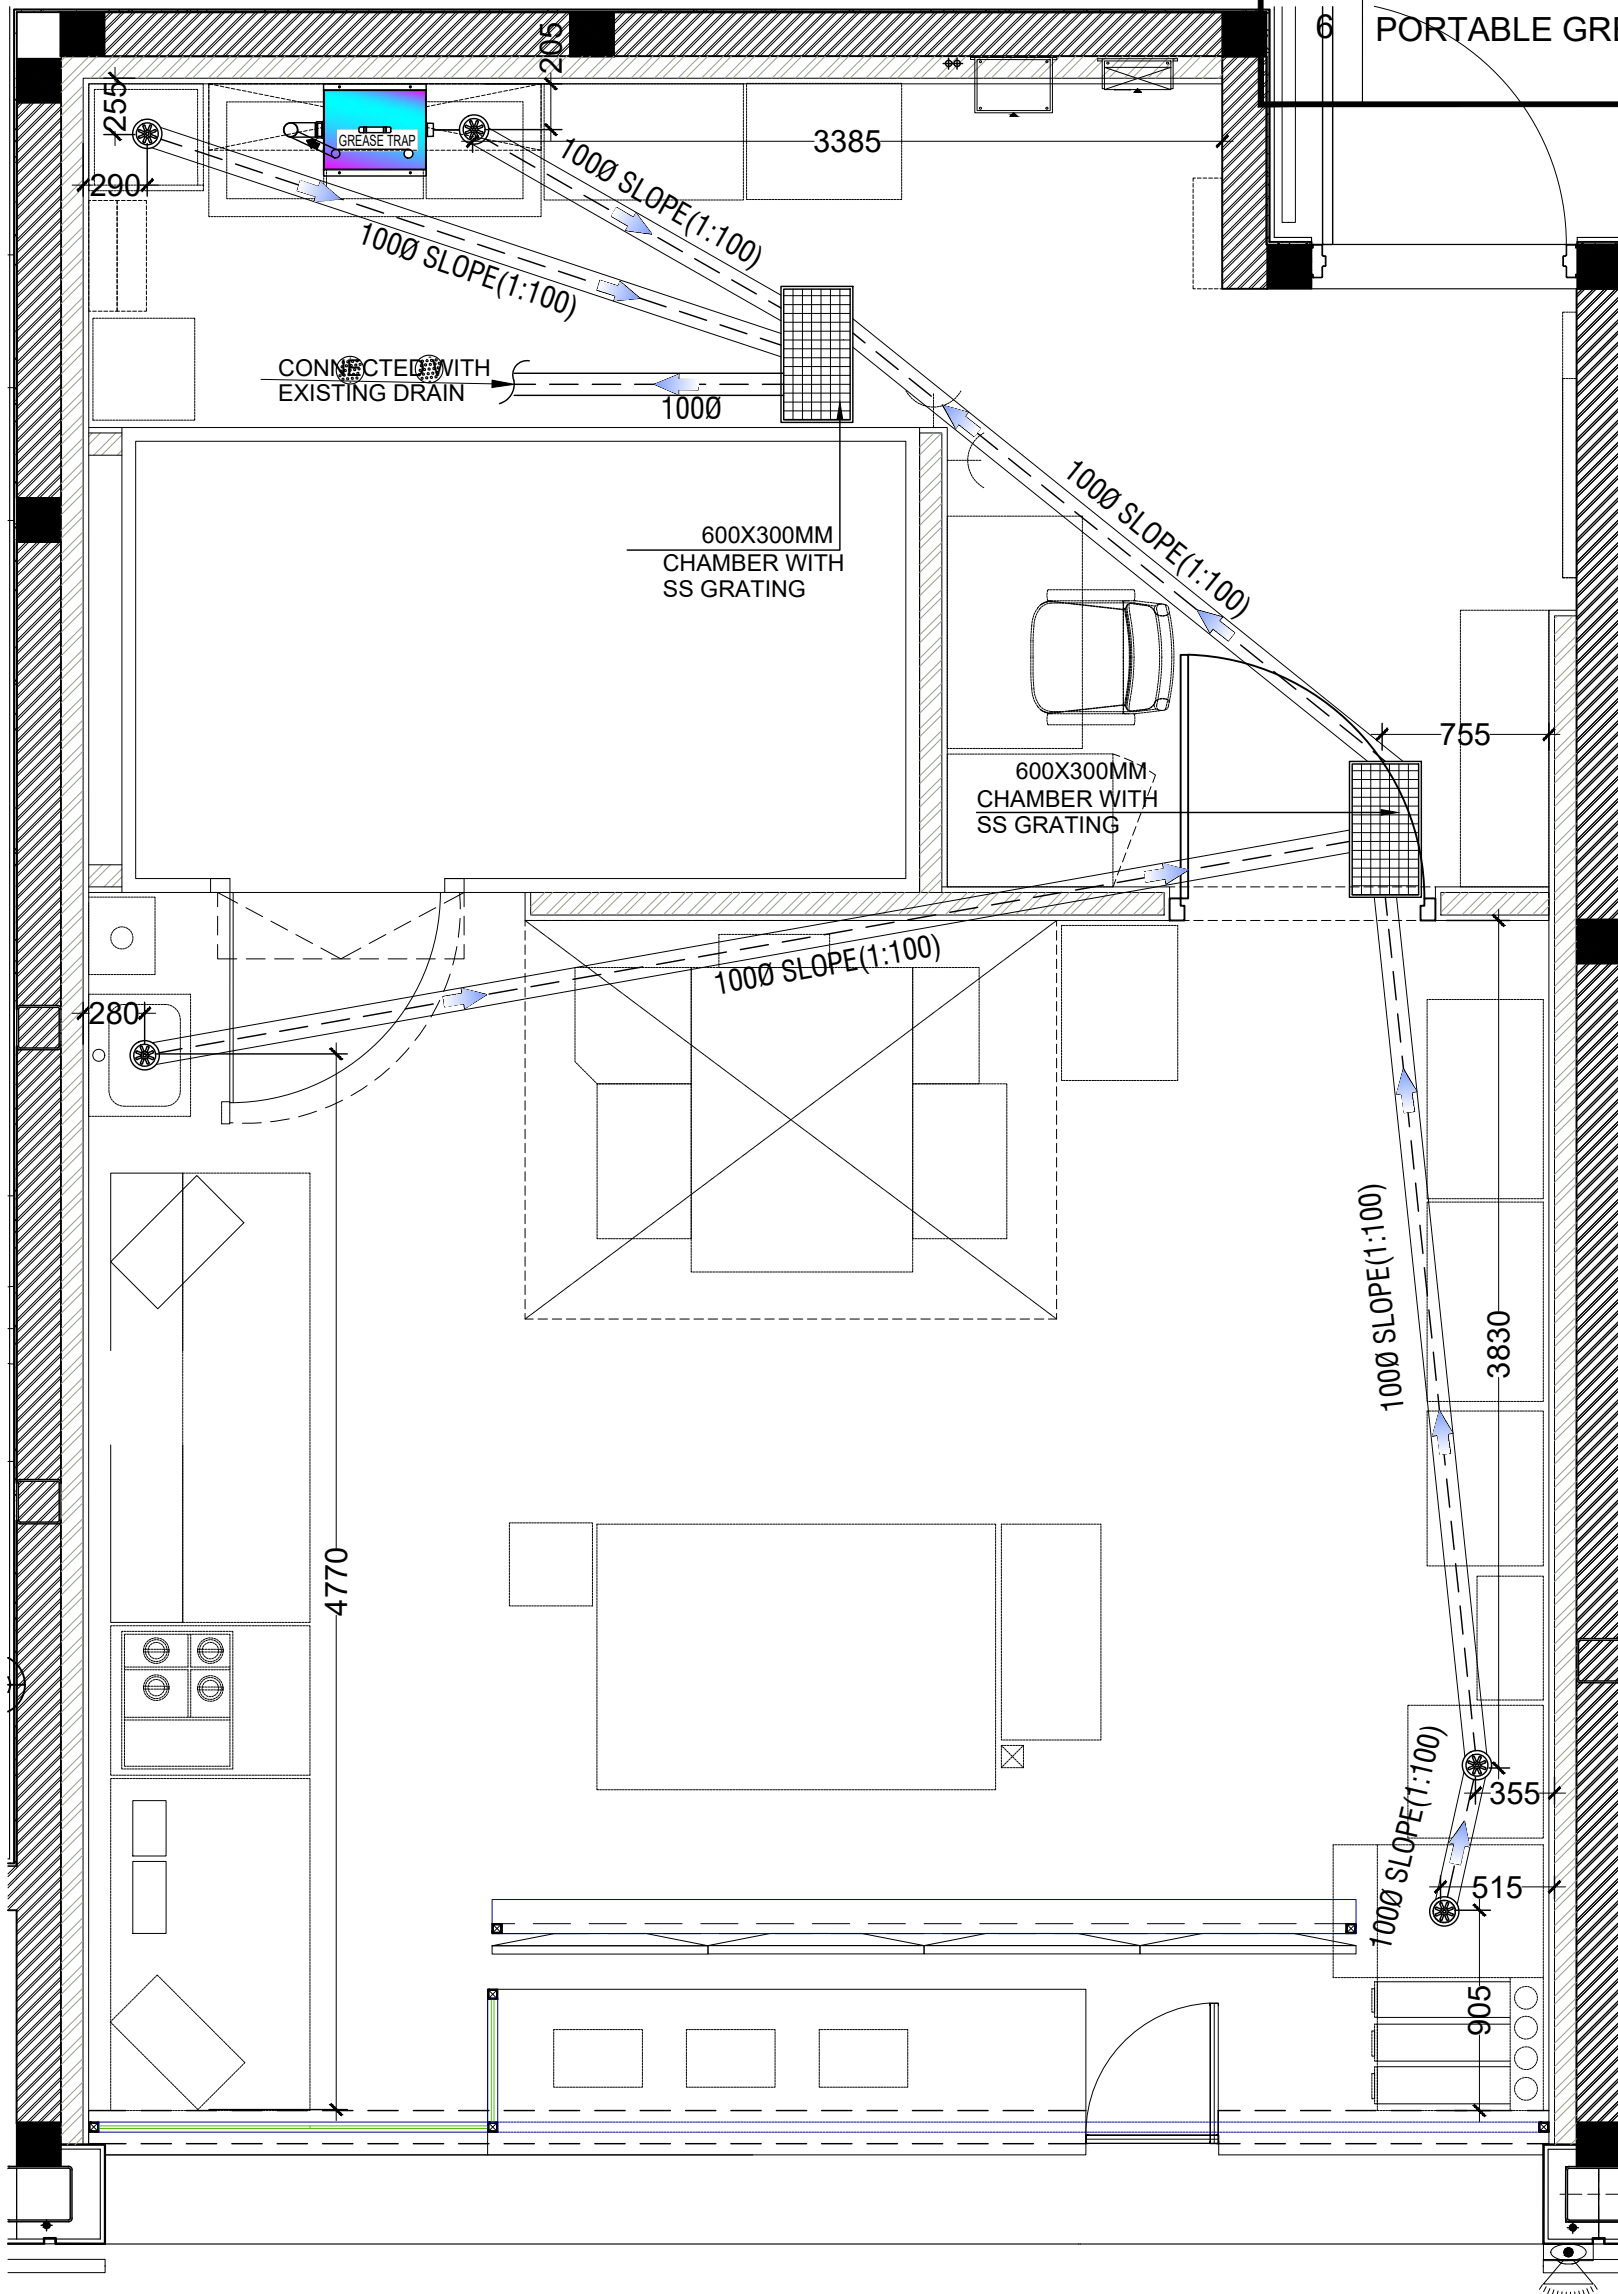Domino's Pizza

JUBILANT FOODWORKS LTD.
(DOMINO'S PIZZA INDIA LTD.)
LOGIX TECHNO PARK, PLOT NO. 5,
TOWER - D, 5th FLOOR,
SECTOR - 127, NOIDA-201304,
PHONE: 0120-4090500, 4090594.

THESE PLANS & SPECIFICATIONS AS WELL AS DOMINO'S NAME & LOGO TRADEMARKS & DESIGNS ARE THE EXCLUSIVE PROPERTY OF JUBILANT COMPANY. ANY REPRODUCTION, MODIFICATION, DISCLOSURE AND/OR USE OF THESE MATERIALS FOR ANY PORTION OF THEM WITHOUT DOMINO'S PRIOR WRITTEN CONSENT IS STRICTLY PROHIBITED.

DISCLAIMER-
IN CASE OF ANY SITE DISCREPANCY, PLEASE GET BACK TO CORPORATE DESIGN TEAM

JUBILANT FOODWORKS INDIA LTD.

PROJ : GMR 1D DELHI
TOTAL AREA : 670 SQFT
KITCHEN AREA : 502 SQFT
BOH AREA : 178 SQFT
ZONE : NORTH
COUNTRY : INDIA.


RESTAURANT NO.:

DRAWN BY : VARUN
CHECKED BY :
ISSUED ON : 26-09-2023

REVISION NO.	REVISION DATE
1	11-10-2023
2	20-10-2023
3	27-10-2023
4	-2022

REMARKS : REVISED AS COMMENT
SCALE : NOT TO SCALE.
SHEET NO. : 14
SHEET TITLE : DRAIN PLAN

WATER SUPPLY LEGEND	
SYMBOL	DESCRIPTION
	RO WATER SUPPLY (ROS)-(CPVC)
	HOT WATER SUPPLY (HWS)-(CPVC)
	DOMESTIC WATER SUPPLY (DWS)-(CPVC)
	BALL VALVE
	INSTANT GEYSER
	DIGITAL WATER METER
	25 LTR. GEYSER 1NO.
	WATER TAP OF POINT

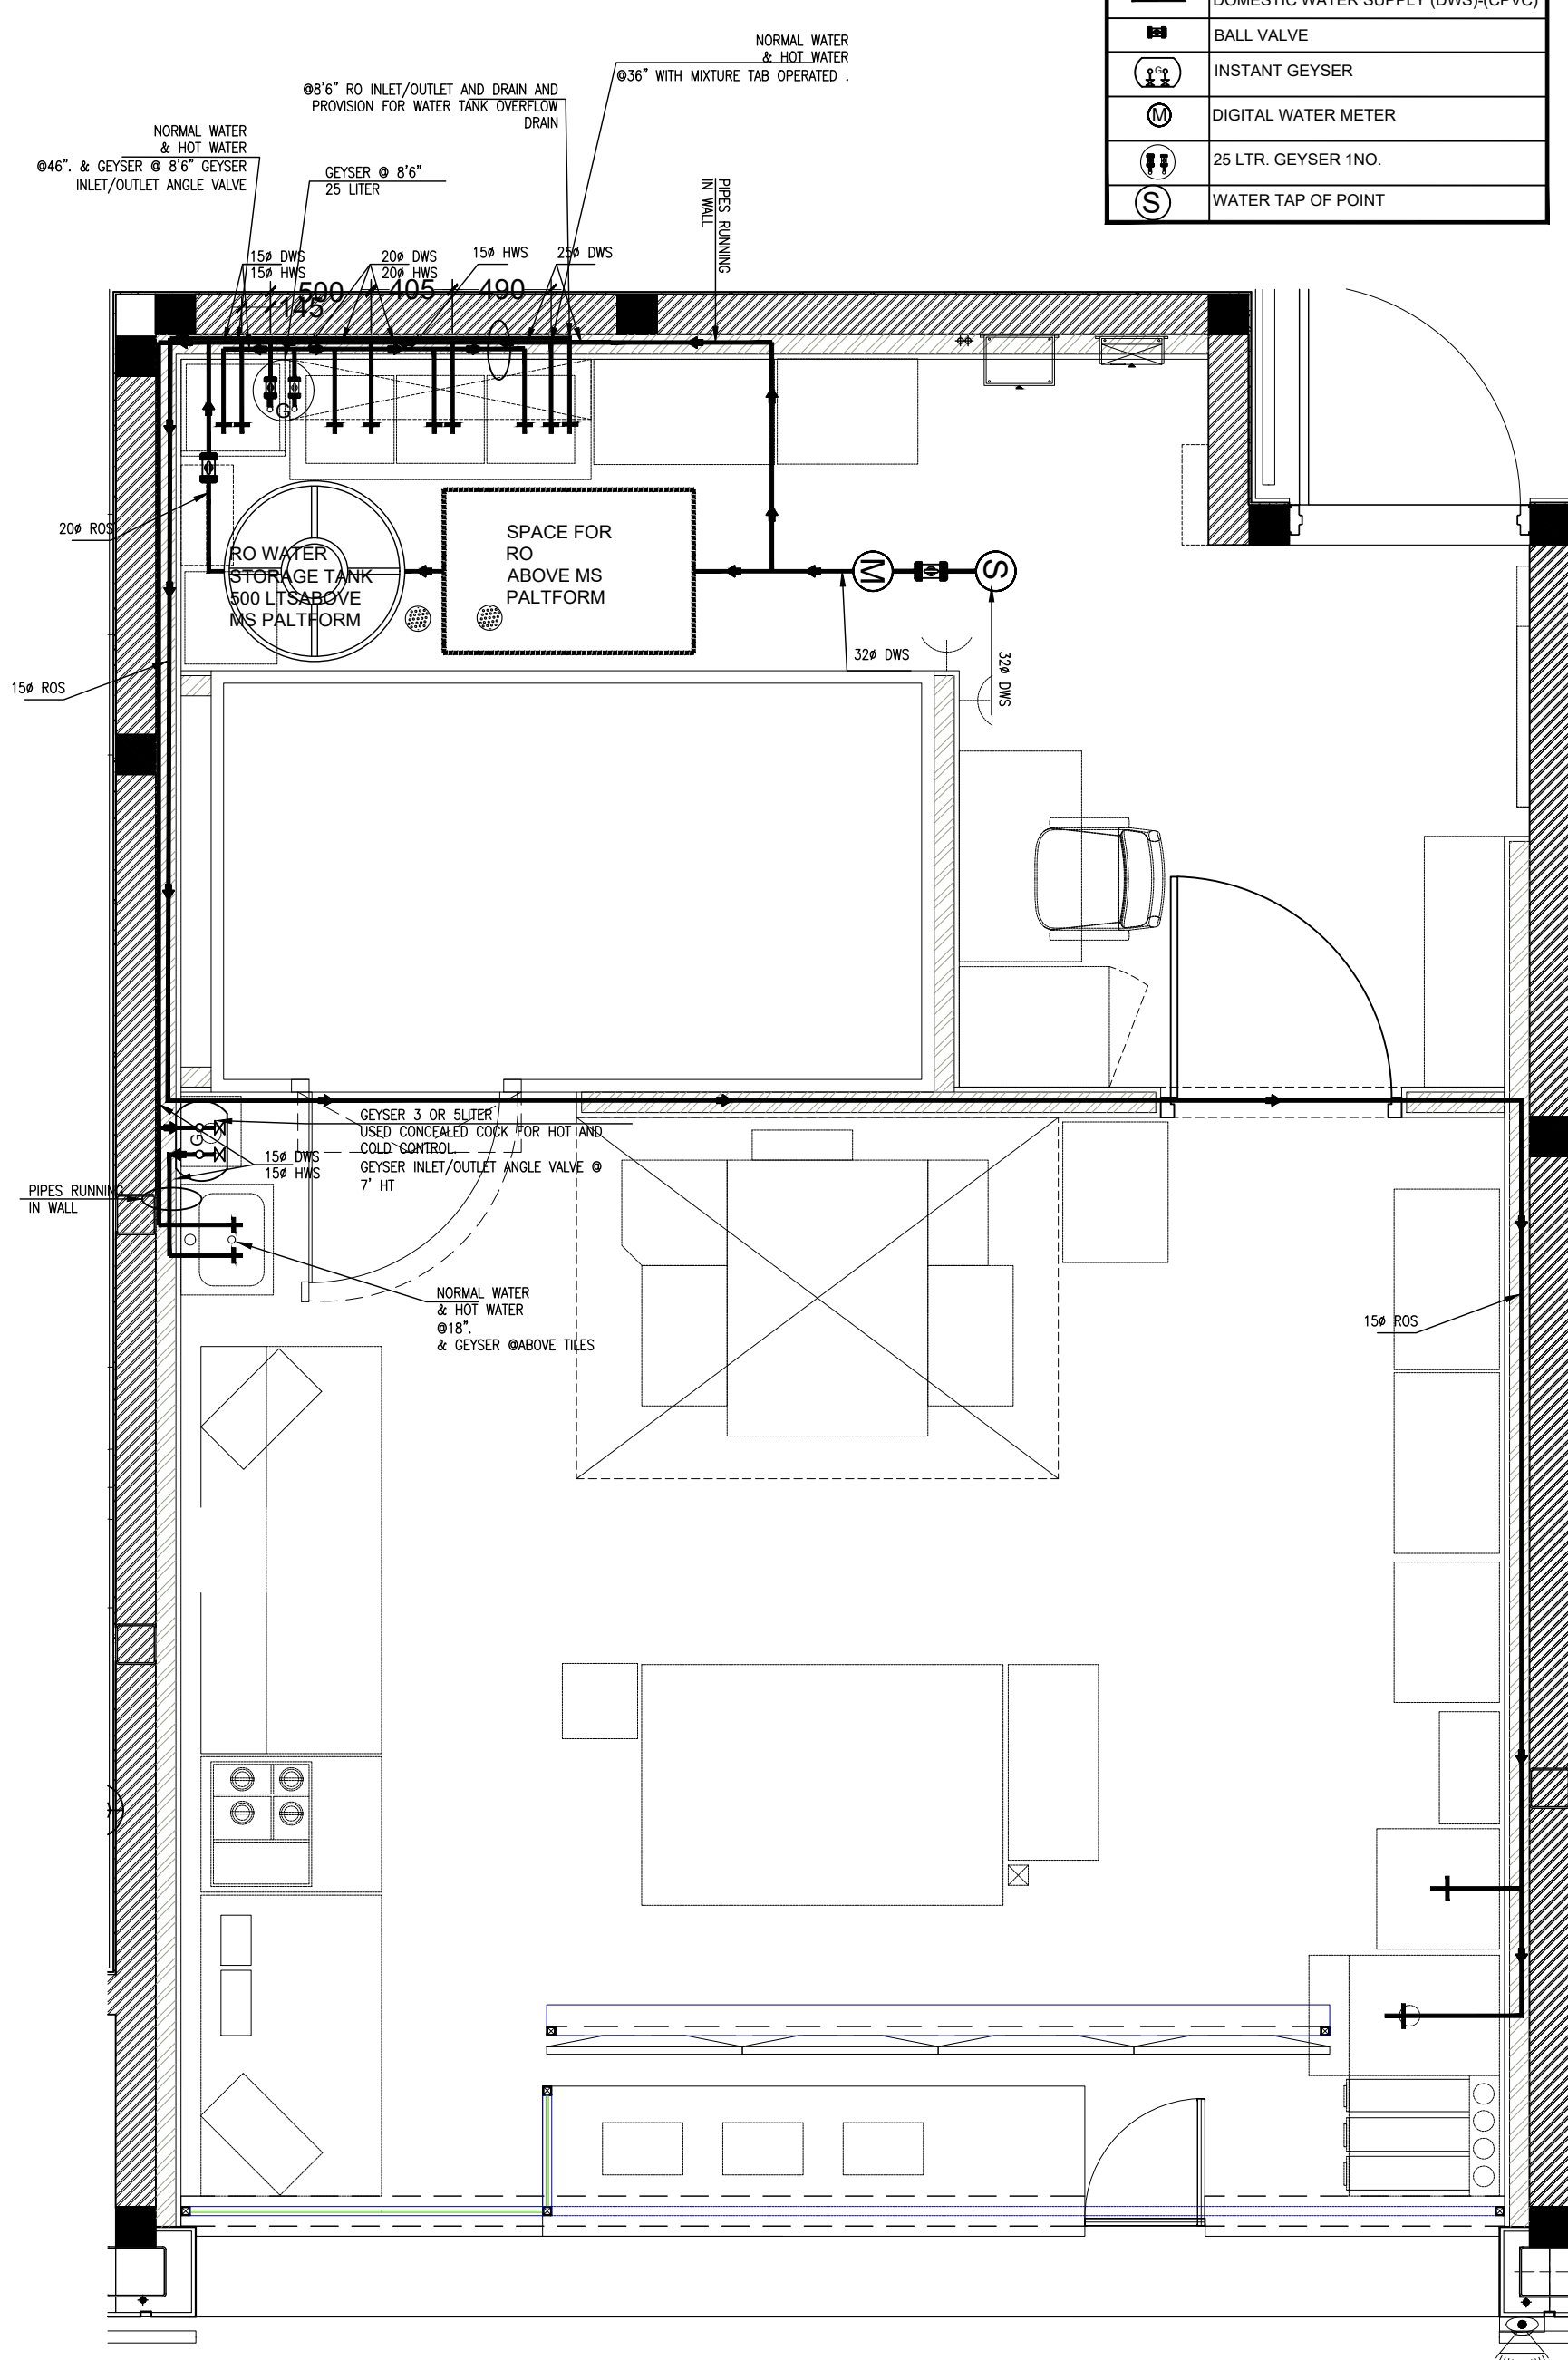



**Domino's
Pizza**

JUBILANT FOODWORKS LTD.
(DOMINO'S PIZZA INDIA LTD.)
LOGIX TECHNO PARK, PLOT NO. 5,
TOWER - D, 5th FLOOR,
SECTOR - 127, NOIDA-201304,
PHONE: 0120-4090500, 4090594.

THESE PLANS & SPECIFICATIONS AS WELL AS DOMINO'S NAME & LOGO, TRADEMARKS & DESIGNS ARE THE EXCLUSIVE PROPERTY OF JUBILANT COMPANY. ANY REPRODUCTION, MODIFICATION, DISCLOSURE AND/OR USE OF THESE MATERIALS (OR BY PORTION OF THEM) WITHOUT DOMINO'S PRIOR WRITTEN CONSENT IS STRICTLY PROHIBITED.

DISCLAIMER-
IN CASE OF ANY SITE DISCREPANCY,
PLEASE GET BACK TO CORPORATE
DESIGN TEAM

JUBILANT FOODWORKS
INDIA LTD.

PROJ	: GMR 1D DELHI
TOTAL AREA	: 670 SQFT
KITCHEN AREA	: 502 SQFT
BOH AREA	: 178 SQFT
ZONE	: NORTH
COUNTRY	: INDIA.

RESTAURANT NO.:

DRAWN BY	: VARUN
CHECKED BY	:
ISSUED ON	: 26-09-2023
REVISION NO.	REVISION DATE
1	11-10-2023
2	20-10-2023
3	27-10-2023
4	-2022


REMARKS : REVISED AS COMMENT


SCALE : NOT TO SCALE.

SHEET NO. : 15

SHEET TITLE : WATER SUPPLY PLAN

SYMBOL	QTY.	ARTICLE NO.	PRODUCT- DESCRIPTION
— — —	-		NORMAL LOOP(R-PHASE)
— — —	-		NORMAL LOOP(Y-PHASE)
— — —	-		NORMAL LOOP(B-PHASE)
— — —	-		EMERGENCY LOOP
⊔ ○	-		SWITCH BOARD NORMAL LIGHT
⊔ ○	-		SWITCH BOARD EMERGENCY LIGHT

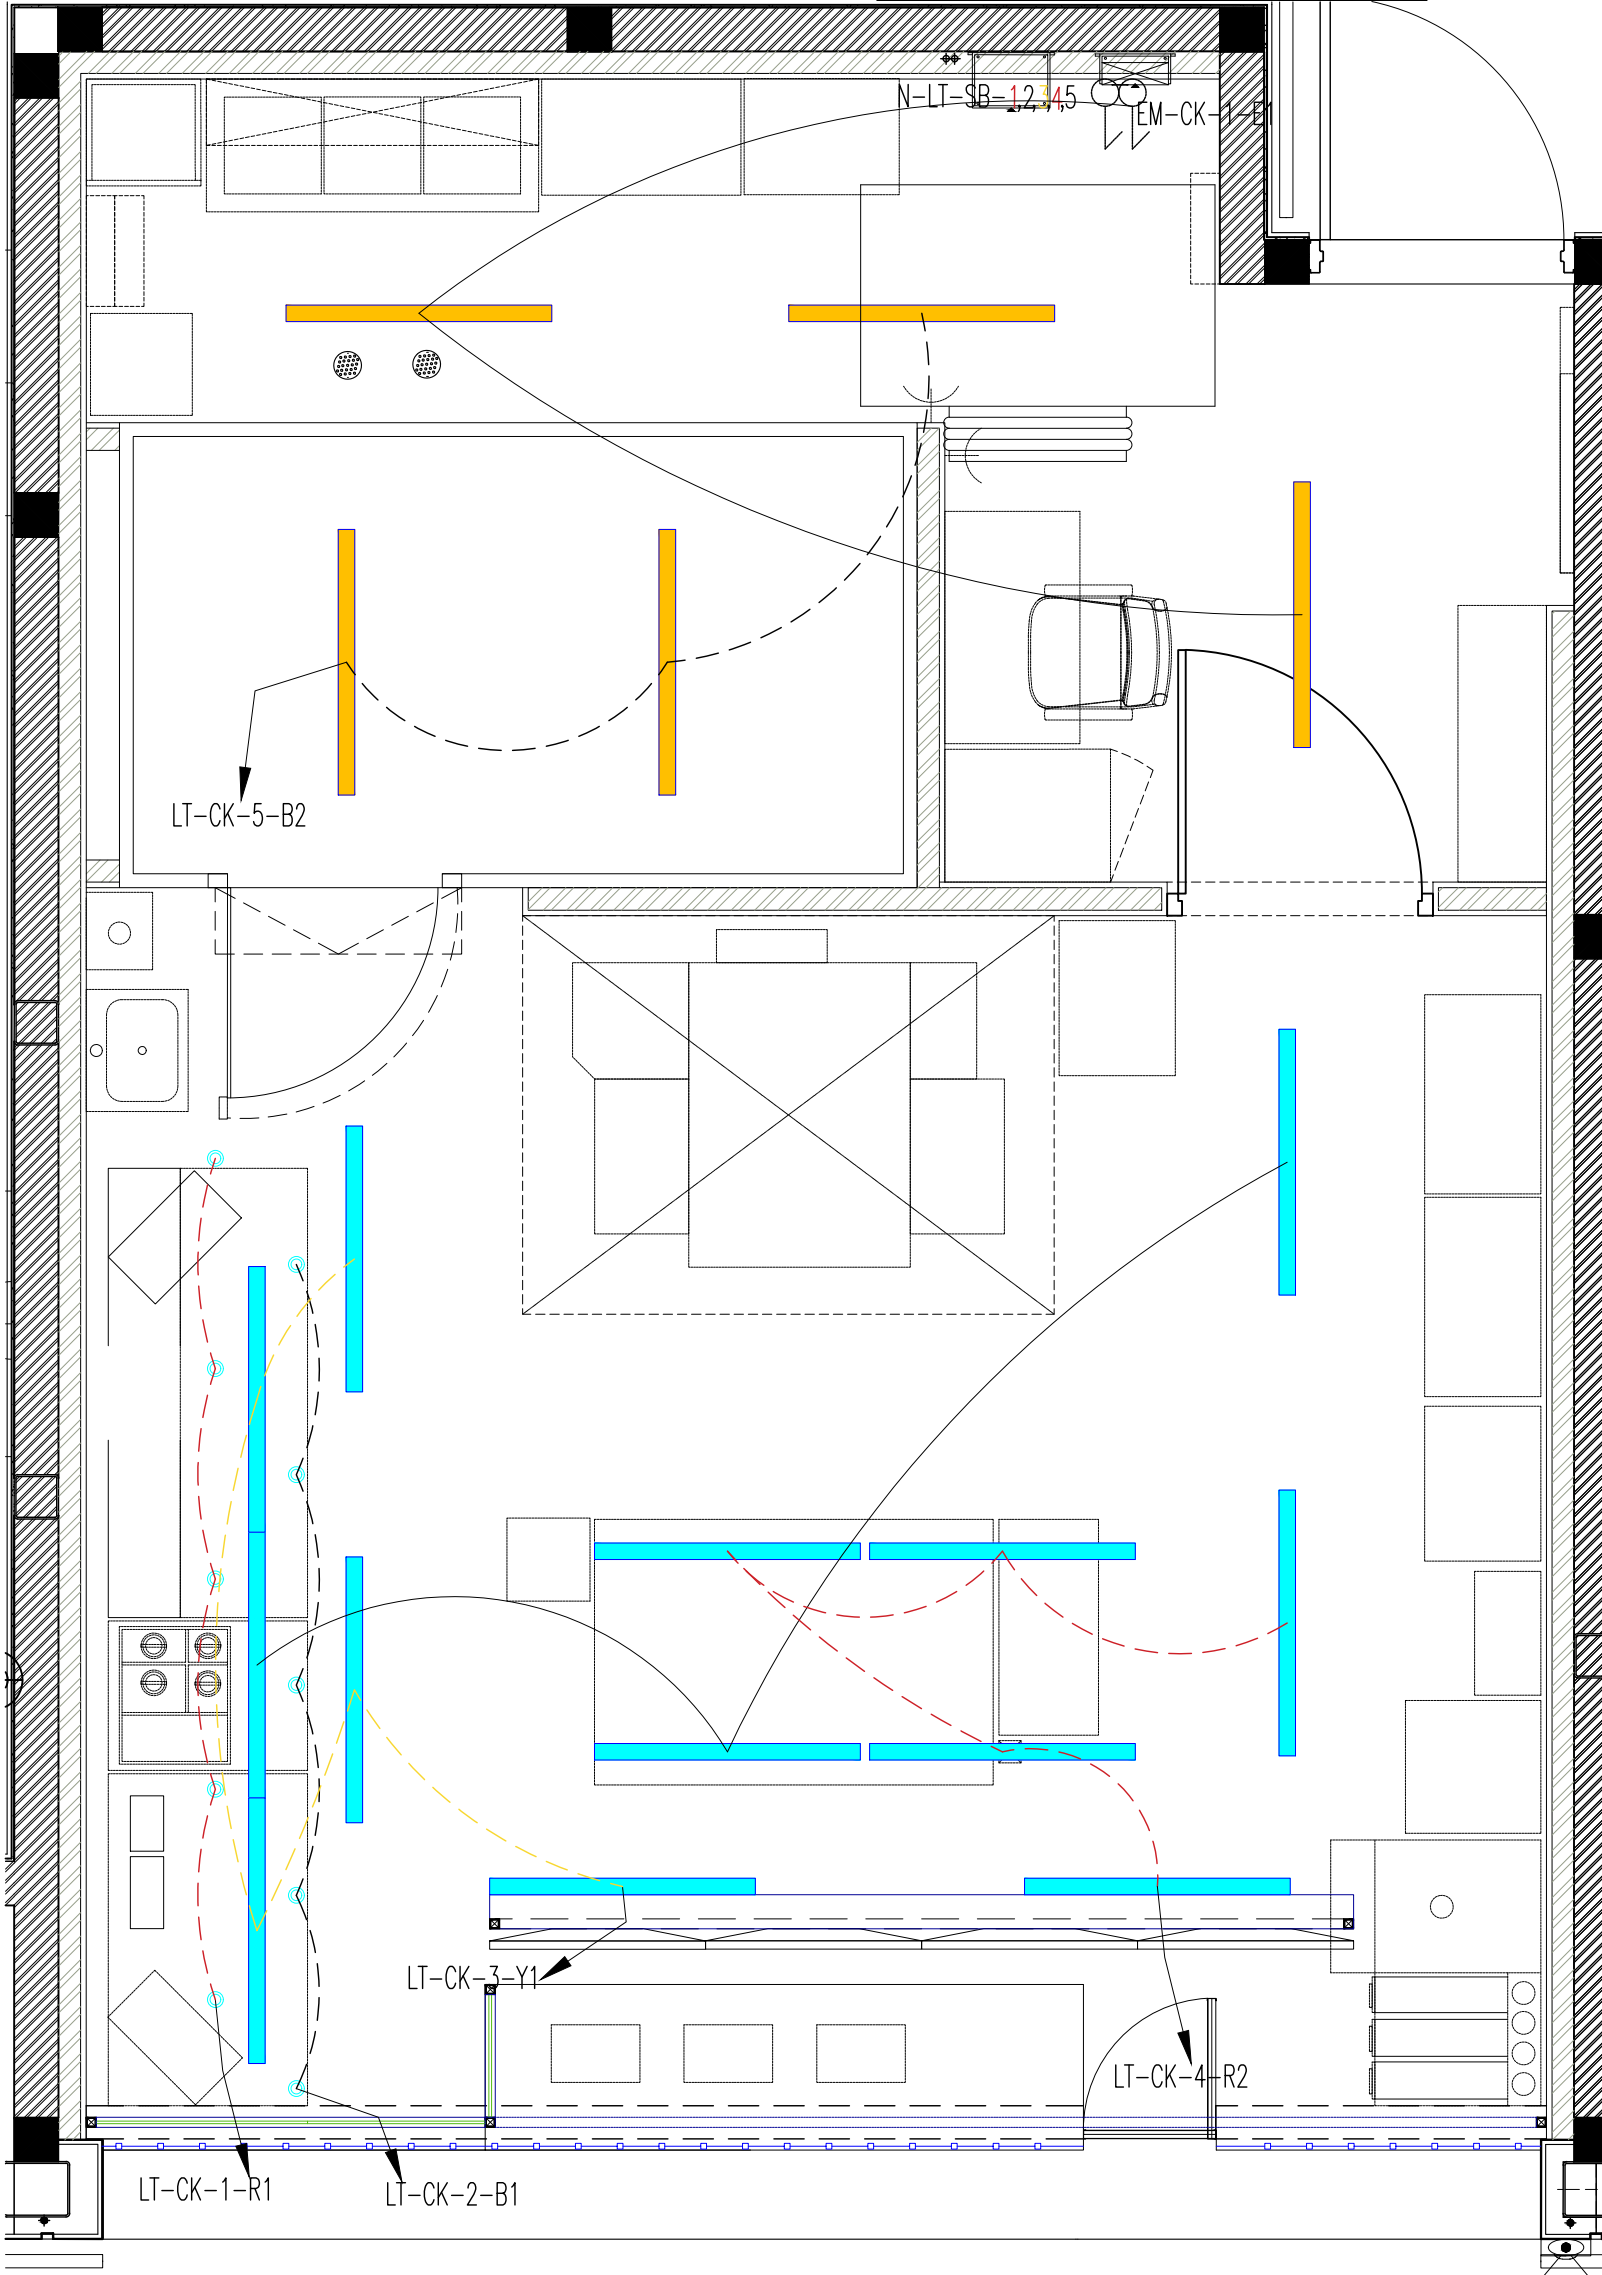

 

**Domino's
Pizza**

JUBILANT FOODWORKS LTD.
(DOMINO'S PIZZA INDIA LTD.)
LOGIX TECHNO PARK, PLOT NO. 5,
TOWER - D, 5th FLOOR,
SECTOR - 127, NOIDA-201304,
PHONE: 0120-4090500, 4090594.

THESE PLANS & SPECIFICATIONS AS WELL AS DOMINO'S
NAME & LOGO TRADEMARKS & DESIGNS ARE THE EXCLUSIVE
PROPERTY OF JUBILANT COMPANY. ANY REPRODUCTION,
MODIFICATION, DISCLOSURE AND/OR USE OF THESE
MATERIALS OR BY PORTION OF THEM WITHOUT DOMINO'S
PRIOR WRITTEN CONSENT IS STRICTLY PROHIBITED.

DISCLAIMER-
IN CASE OF ANY SITE DISCREPANCY,
PLEASE GET BACK TO CORPORATE
DESIGN TEAM

JUBILANT FOODWORKS
INDIA LTD.



PROJ : GMR 1D DELHI
TOTAL AREA : 670 SQFT
KITCHEN AREA : 502 SQFT
BOH AREA : 178 SQFT
ZONE : NORTH
COUNTRY : INDIA.

RESTAURANT NO.:

DRAWN BY : VARUN
CHECKED BY :
ISSUED ON : 26-09-2023

REVISION NO.	REVISION DATE
1	11-10-2023
2	20-10-2023
3	27-10-2023
4	-2022

REMARKS : REVISED AS COMMENT
SCALE : NOT TO SCALE
SHEET NO. : 16
SHEET TITLE : LOOPING PLAN

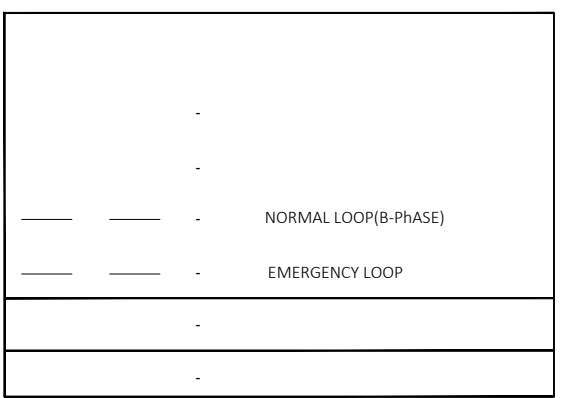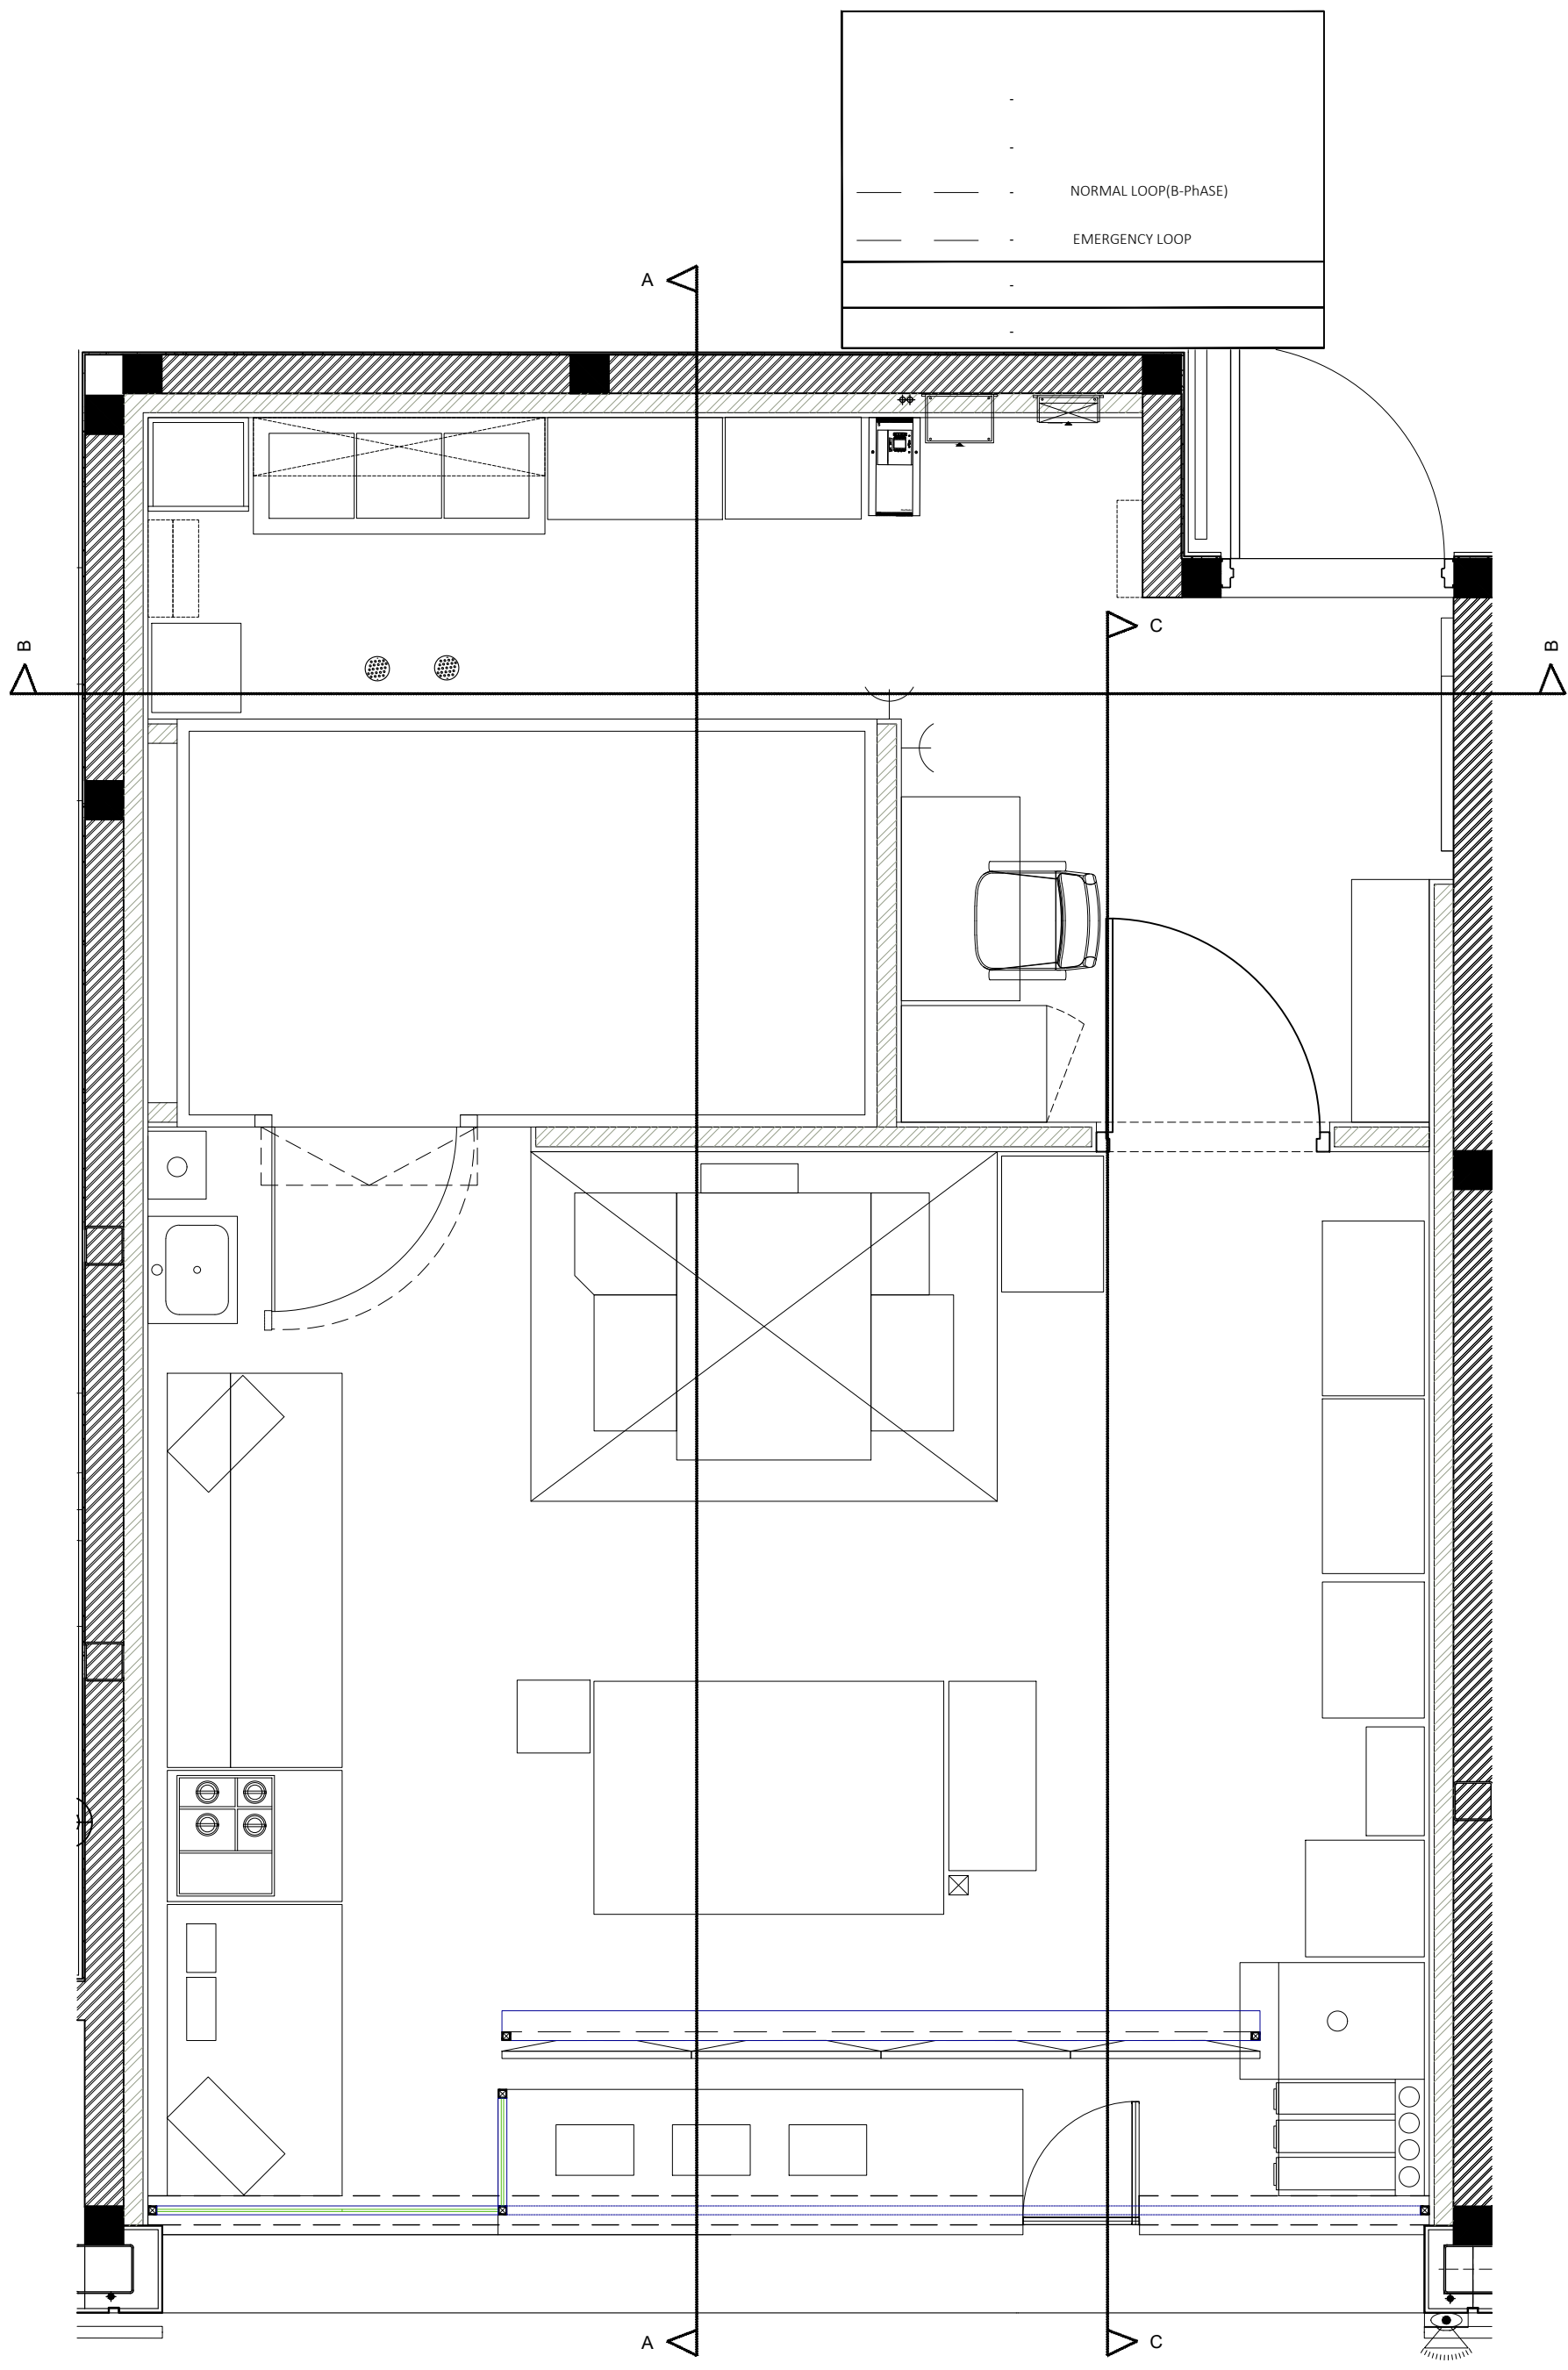



**Domino's
Pizza**

JUBILANT FOODWORKS LTD.
(DOMINO'S PIZZA INDIA LTD.)
LOGIX TECHNO PARK, PLOT NO. 5,
TOWER - D, 5th FLOOR,
SECTOR - 127, NOIDA-201304.
PHONE: 0120-4090500, 4090594.

THESE PLANS & SPECIFICATIONS AS WELL AS DOMINO'S
NAME & LOGO, TRADEMARKS & DESIGNS ARE THE EXCLUSIVE
PROPERTY OF JUBILANT COMPANY. ANY REPRODUCTION,
MODIFICATION, DISCLOSURE AND/OR USE OF THESE
MATERIALS (OR BY PORTION OF THEM) WITHOUT DOMINO'S
PRIOR WRITTEN CONSENT IS STRICTLY PROHIBITED.

DISCLAIMER-
IN CASE OF ANY SITE DISCREPANCY,
PLEASE GET BACK TO CORPORATE
DESIGN TEAM

JUBILANT FOODWORKS
INDIA LTD.


PROJ : GMR 1D DELHI
TOTAL AREA : 670 SQFT
KITCHEN AREA : 502 SQFT
BOH AREA : 178 SQFT
ZONE : NORTH
COUNTRY : INDIA.

RESTAURANT NO.:

DRAWN BY : VARUN
CHECKED BY :
ISSUED ON : 26-09-2023

REVISION NO.	REVISION DATE
1	11-10-2023
2	20-10-2023
3	27-10-2023
4	-2022

REMARKS : REVISED AS COMMENT
SCALE : NOT TO SCALE
SHEET NO. : 17
SHEET TITLE : SECTION PLAN

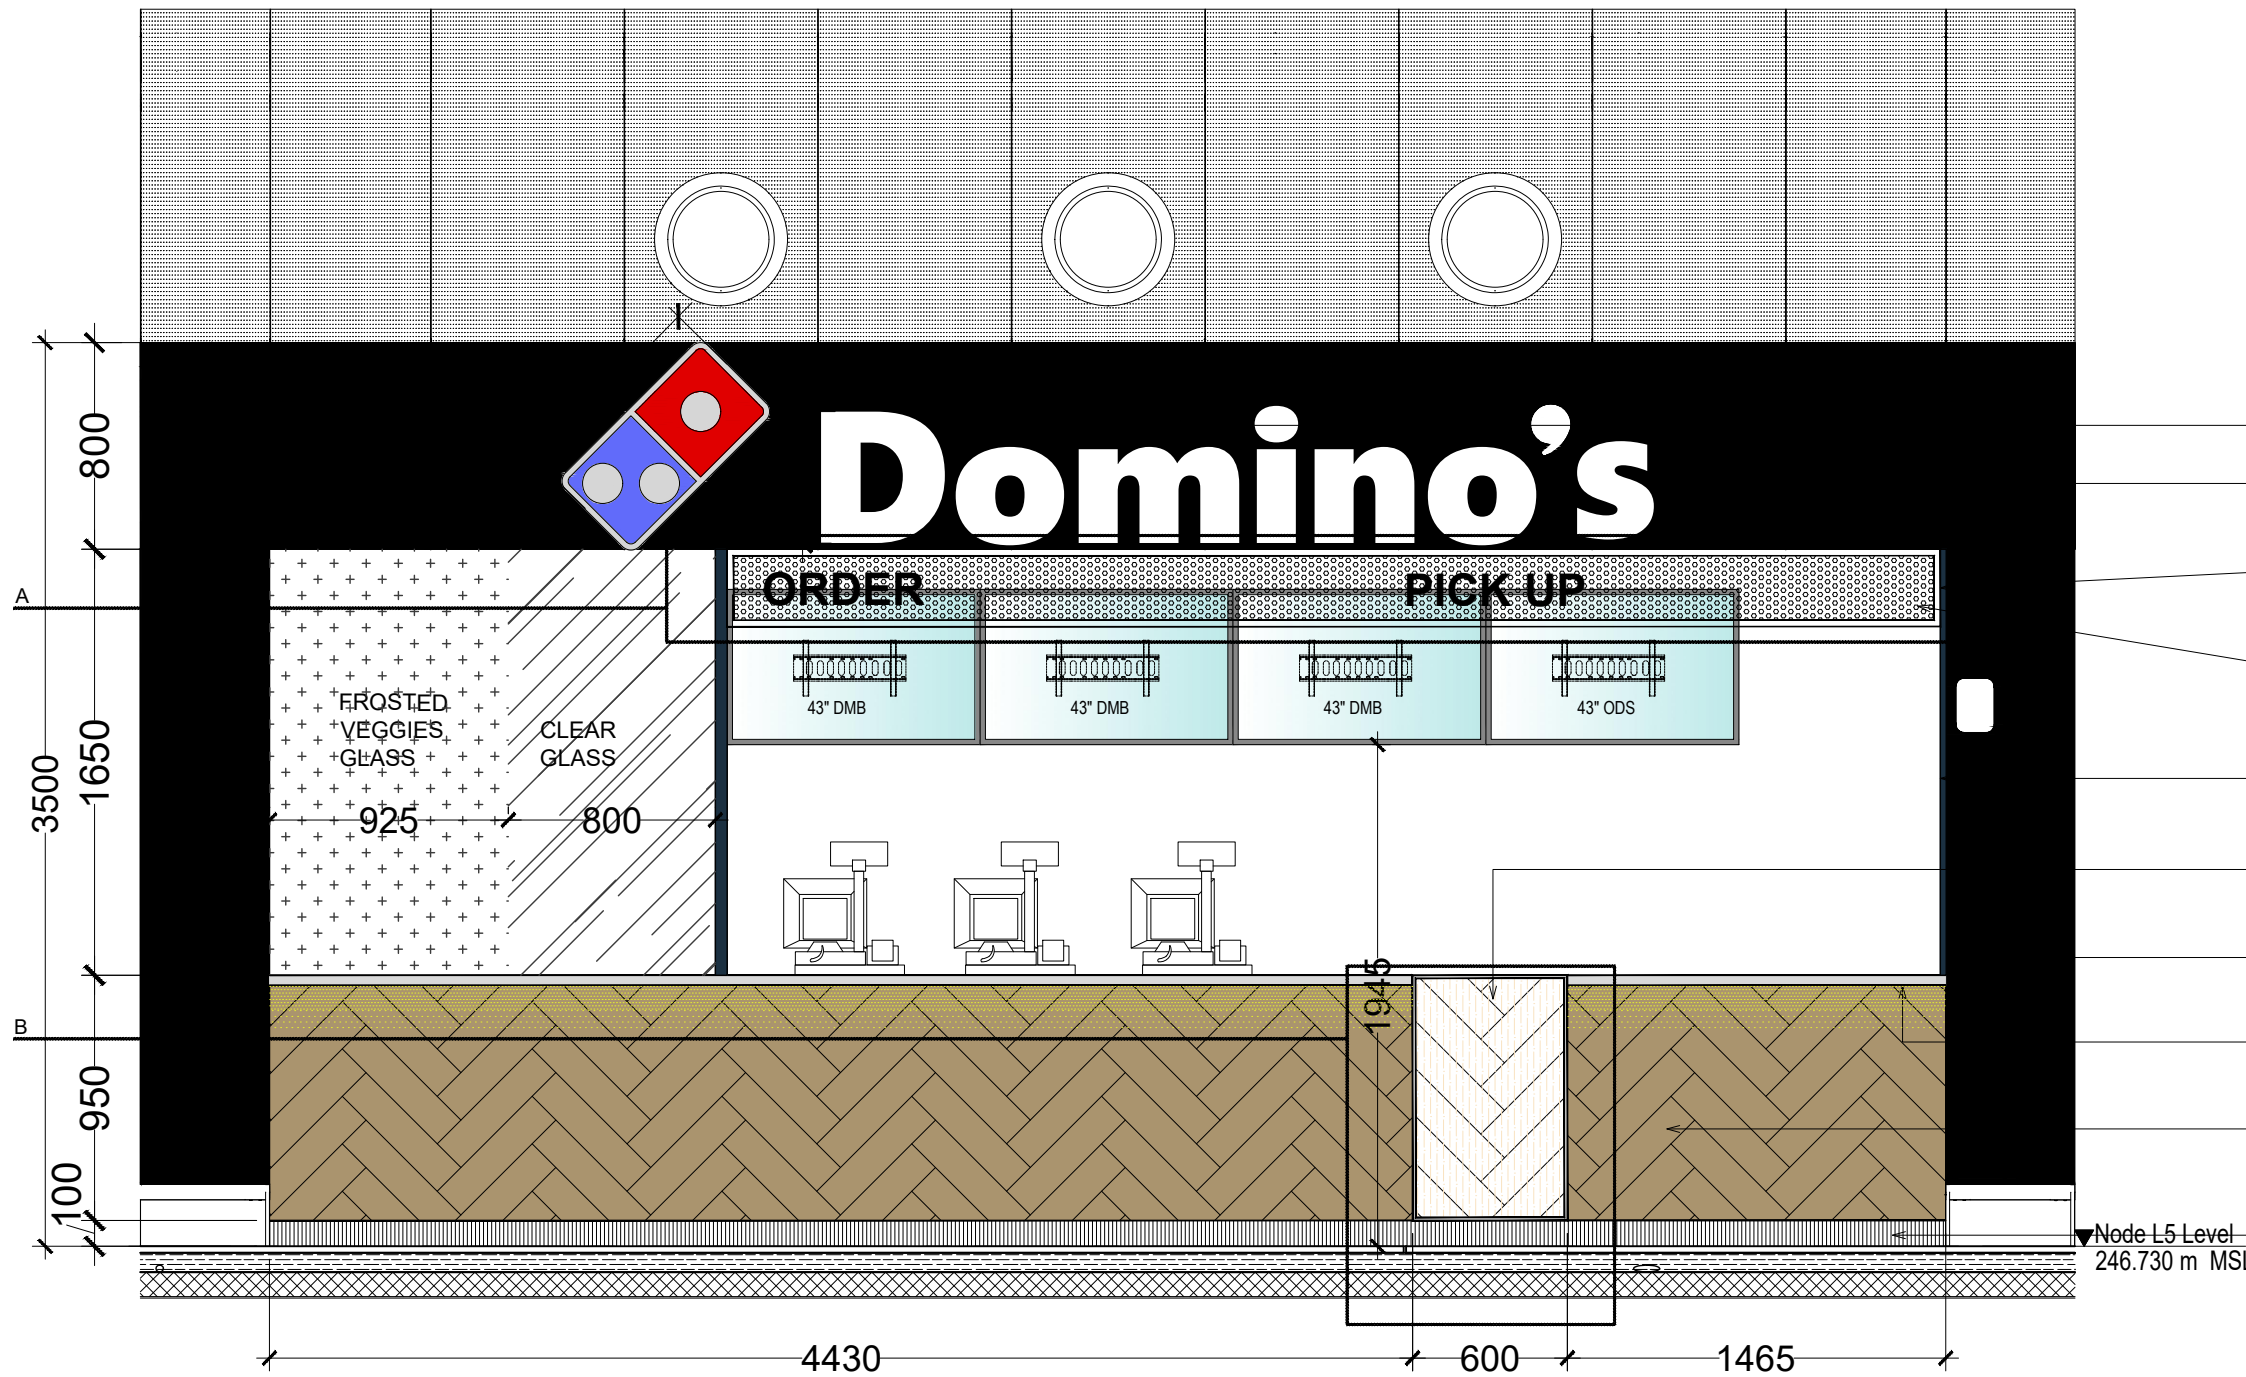

3D SELF LIT BRAND LOGO
 ACP AS PER SITE CONDITION

MESH WITH 25X25 MM FRAMING ALL AROUND FOR '2"ORDER & PICK-UP' LETTERS PT-03

10 MM THK PERFORATED JALI OVER 3 MM SHEET PT-03
 40MM X40 MM M.S. HOLLOW PIPE STRUCTURE SUSPENDED FROM SLAB, FINISHED WITH MATT POWDER COAT PAINT PT-03

LAMINATE DOOR MATCHING WITH SHEESHAM ROSEWOOD WITH 2 MM GROOVE (NOVA TEAM 10091-MARINOLAM) AS/SITE CONDITION

6 MM THK.LG HAUSYS G-109 HI MACS OVER 19 MM THK BISON COVE LIGHT UNDER COUNTER LEDGE

KAJARIA - 130X800MM SHEESHAM ROSEWOOD (HARRYING BONE PATTEN)

SKIRTING AS/SITE CONDITION

Node L5 Level
 246.730 m MSL

SHOP FRONT

SCALE: NTS



Domino's Pizza

JUBILANT FOODWORKS LTD.
 (DOMINO'S PIZZA INDIA LTD.)
 LOGIX TECHNO PARK, PLOT NO. 5,
 TOWER - D, 5th FLOOR,
 SECTOR - 127, NOIDA-201304.
 PHONE: 0120-4090500, 4090594.

THESE PLANS & SPECIFICATIONS AS WELL AS DOMINO'S NAME & LOGO, TRADEMARKS & DESIGNS ARE THE EXCLUSIVE PROPERTY OF JUBILANT COMPANY. ANY REPRODUCTION, MODIFICATION, DISCLOSURE AND/OR USE OF THESE MATERIALS OR BY PORTION OF THEM WITHOUT DOMINO'S PRIOR WRITTEN CONSENT IS STRICTLY PROHIBITED.

DISCLAIMER-
 IN CASE OF ANY SITE DISCREPANCY, PLEASE GET BACK TO CORPORATE DESIGN TEAM

JUBILANT FOODWORKS INDIA LTD.


PROJ : GMR 1D DELHI
 TOTAL AREA : 670 SQFT
 KITCHEN AREA : 502 SQFT
 BOH AREA : 178 SQFT
 ZONE : NORTH
 COUNTRY : INDIA.

RESTAURANT NO.:

DRAWN BY : VARUN
 CHECKED BY :
 ISSUED ON : 26-09-2023

REVISION NO.	REVISION DATE
1	11-10-2023
2	20-10-2023
3	27-10-2023
4	-2022

REMARKS : REVISED AS/COMMENT
 SCALE : NOT TO SCALE
 SHEET NO. : 18
 SHEET TITLE : ELEVATION

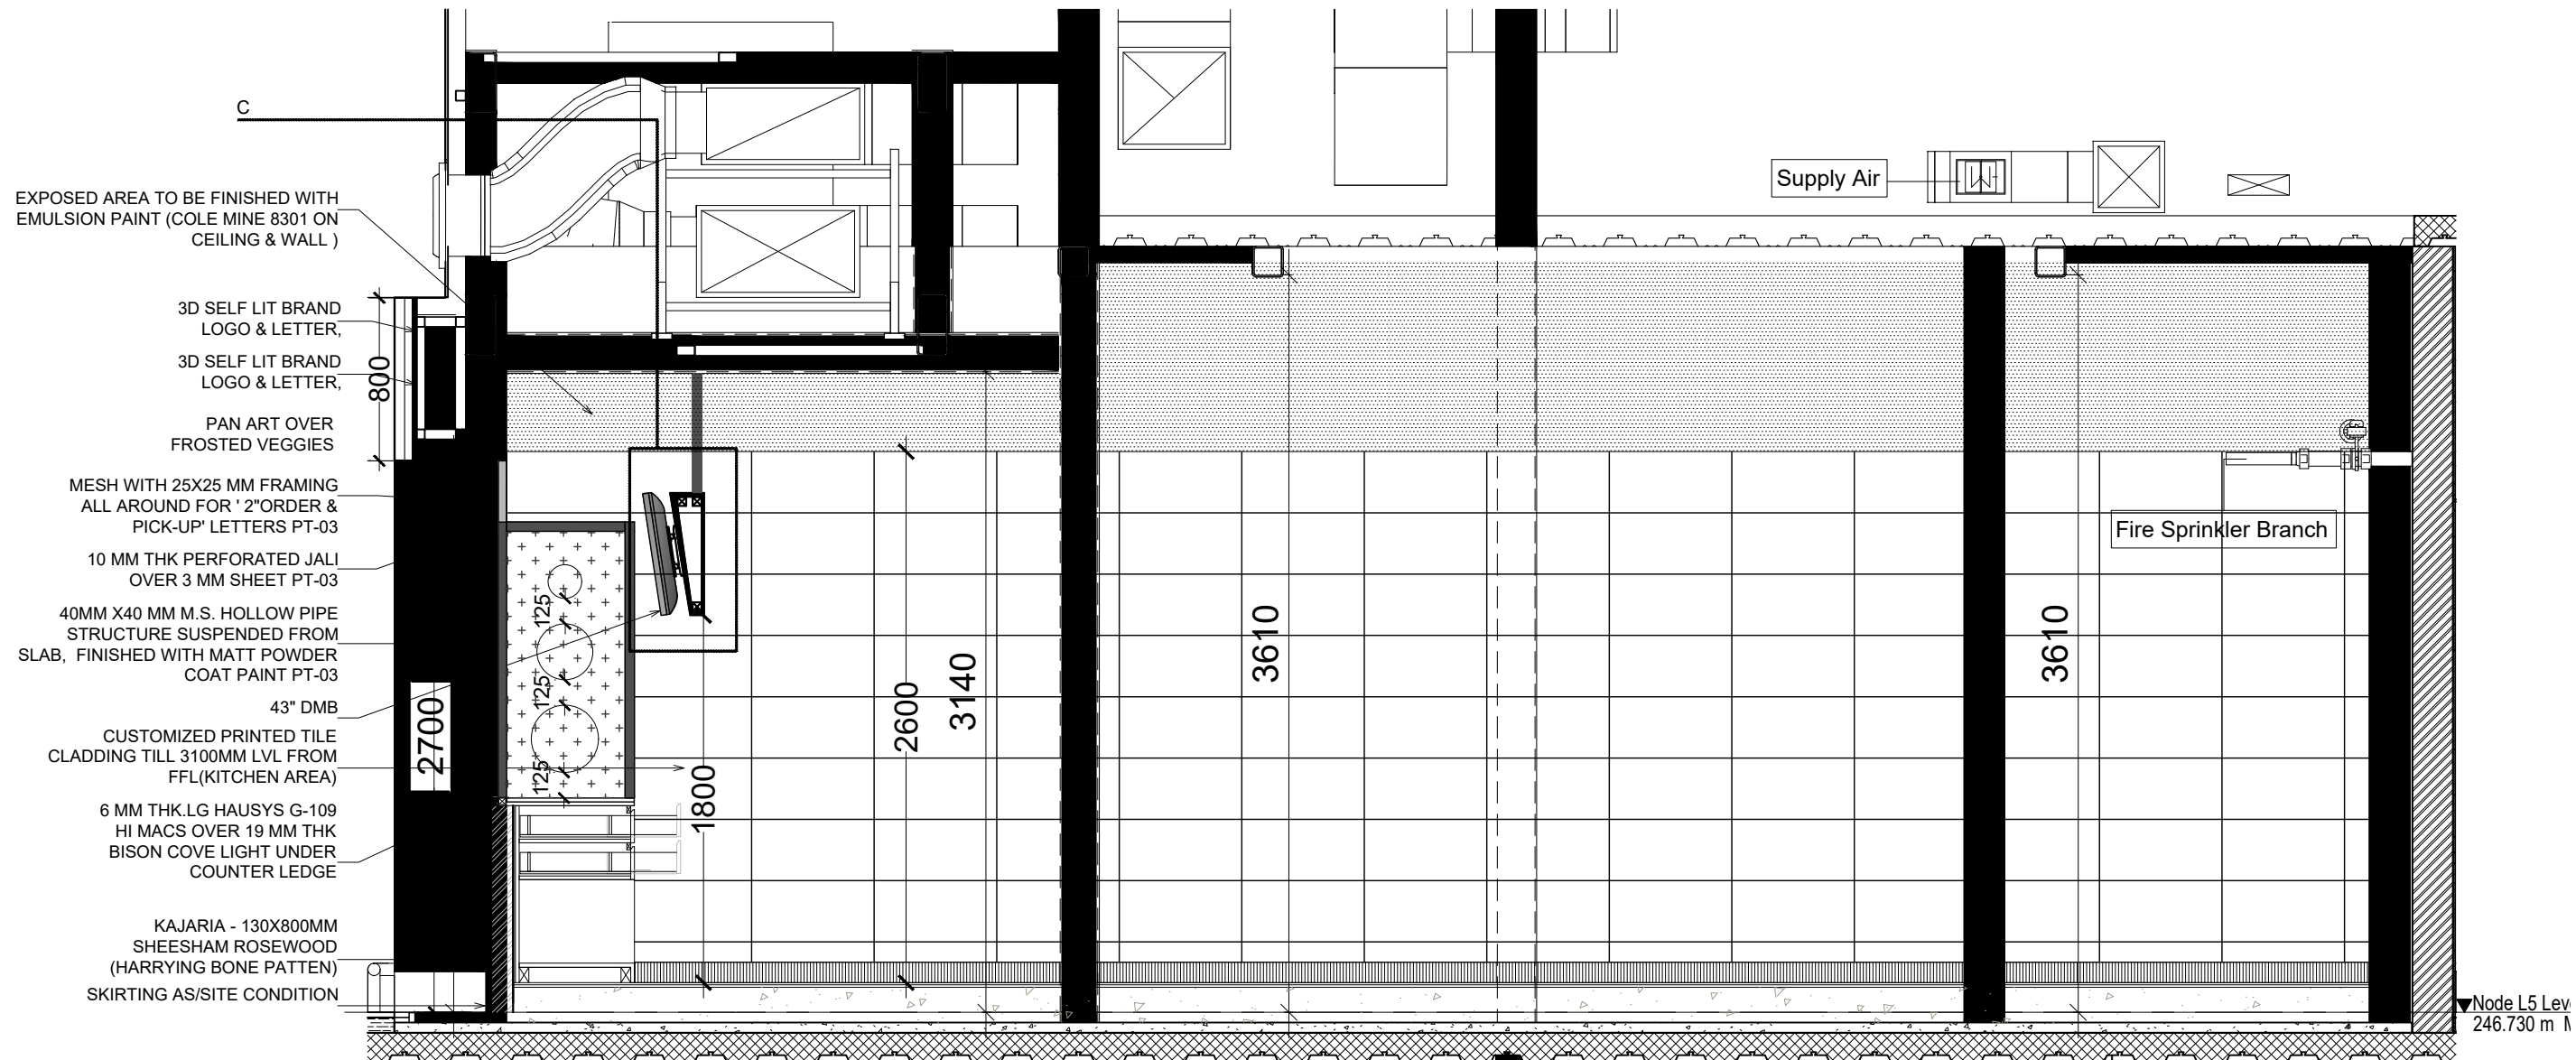

- EXPOSED AREA TO BE FINISHED WITH EMULSION PAINT (COLE MINE 8301 ON CEILING & WALL)
- 3D SELF LIT BRAND LOGO & LETTER,
- 3D SELF LIT BRAND LOGO & LETTER,
- 800
- PAN ART OVER FROSTED VEGGIES
- MESH WITH 25X25 MM FRAMING ALL AROUND FOR '2"ORDER & PICK-UP' LETTERS PT-03
- 10 MM THK PERFORATED JALI OVER 3 MM SHEET PT-03
- 40MM X40 MM M.S. HOLLOW PIPE STRUCTURE SUSPENDED FROM SLAB, FINISHED WITH MATT POWDER COAT PAINT PT-03
- 43" DMB
- CUSTOMIZED PRINTED TILE CLADDING TILL 3100MM LVL FROM FFL(KITCHEN AREA)
- 6 MM THK.LG HAUSYS G-109 HI MACS OVER 19 MM THK BISON COVE LIGHT UNDER COUNTER LEDGE
- 1800
- KAJARIA - 130X800MM SHEESHAM ROSEWOOD (HARRYING BONE PATTEN) SKIRTING AS/SITE CONDITION

SECTION 'A'
SCALE: NTS

Node L5 Lev.
246.730 m N



**Domino's
Pizza**

JUBILANT FOODWORKS LTD.
(DOMINO'S PIZZA INDIA LTD.)
LOGIX TECHNO PARK, PLOT NO. 5,
TOWER - D, 5th FLOOR,
SECTOR - 127, NOIDA-201304,
PHONE: 0120-4090500, 4090594.

THESE PLANS & SPECIFICATIONS AS WELL AS DOMINO'S NAME & LOGO, TRADEMARKS & DESIGNS ARE THE EXCLUSIVE PROPERTY OF JUBILANT COMPANY. ANY REPRODUCTION, MODIFICATION, DISCLOSURE AND/OR USE OF THESE MATERIALS (OR BY PORTION OF THEM) WITHOUT DOMINO'S PRIOR WRITTEN CONSENT IS STRICTLY PROHIBITED.

DISCLAIMER-
IN CASE OF ANY SITE DISCREPANCY, PLEASE GET BACK TO CORPORATE DESIGN TEAM

JUBILANT FOODWORKS INDIA LTD.

PROJ	: GMR 1D DELHI
TOTAL AREA	: 670 SQFT
KITCHEN AREA	: 502 SQFT
BOH AREA	: 178 SQFT
ZONE	: NORTH
COUNTRY	: INDIA.

RESTAURANT NO.:

DRAWN BY	: VARUN
CHECKED BY	:
ISSUED ON	: 26-09-2023


REVISION NO.	REVISION DATE
1	11-10-2023
2	20-10-2023
3	27-10-2023
4	-2022

REMARKS : REVISED AS/COMMENT

SCALE : NOT TO SCALE.


SHEET NO. : 19

SHEET TITLE : SECTION 'A'

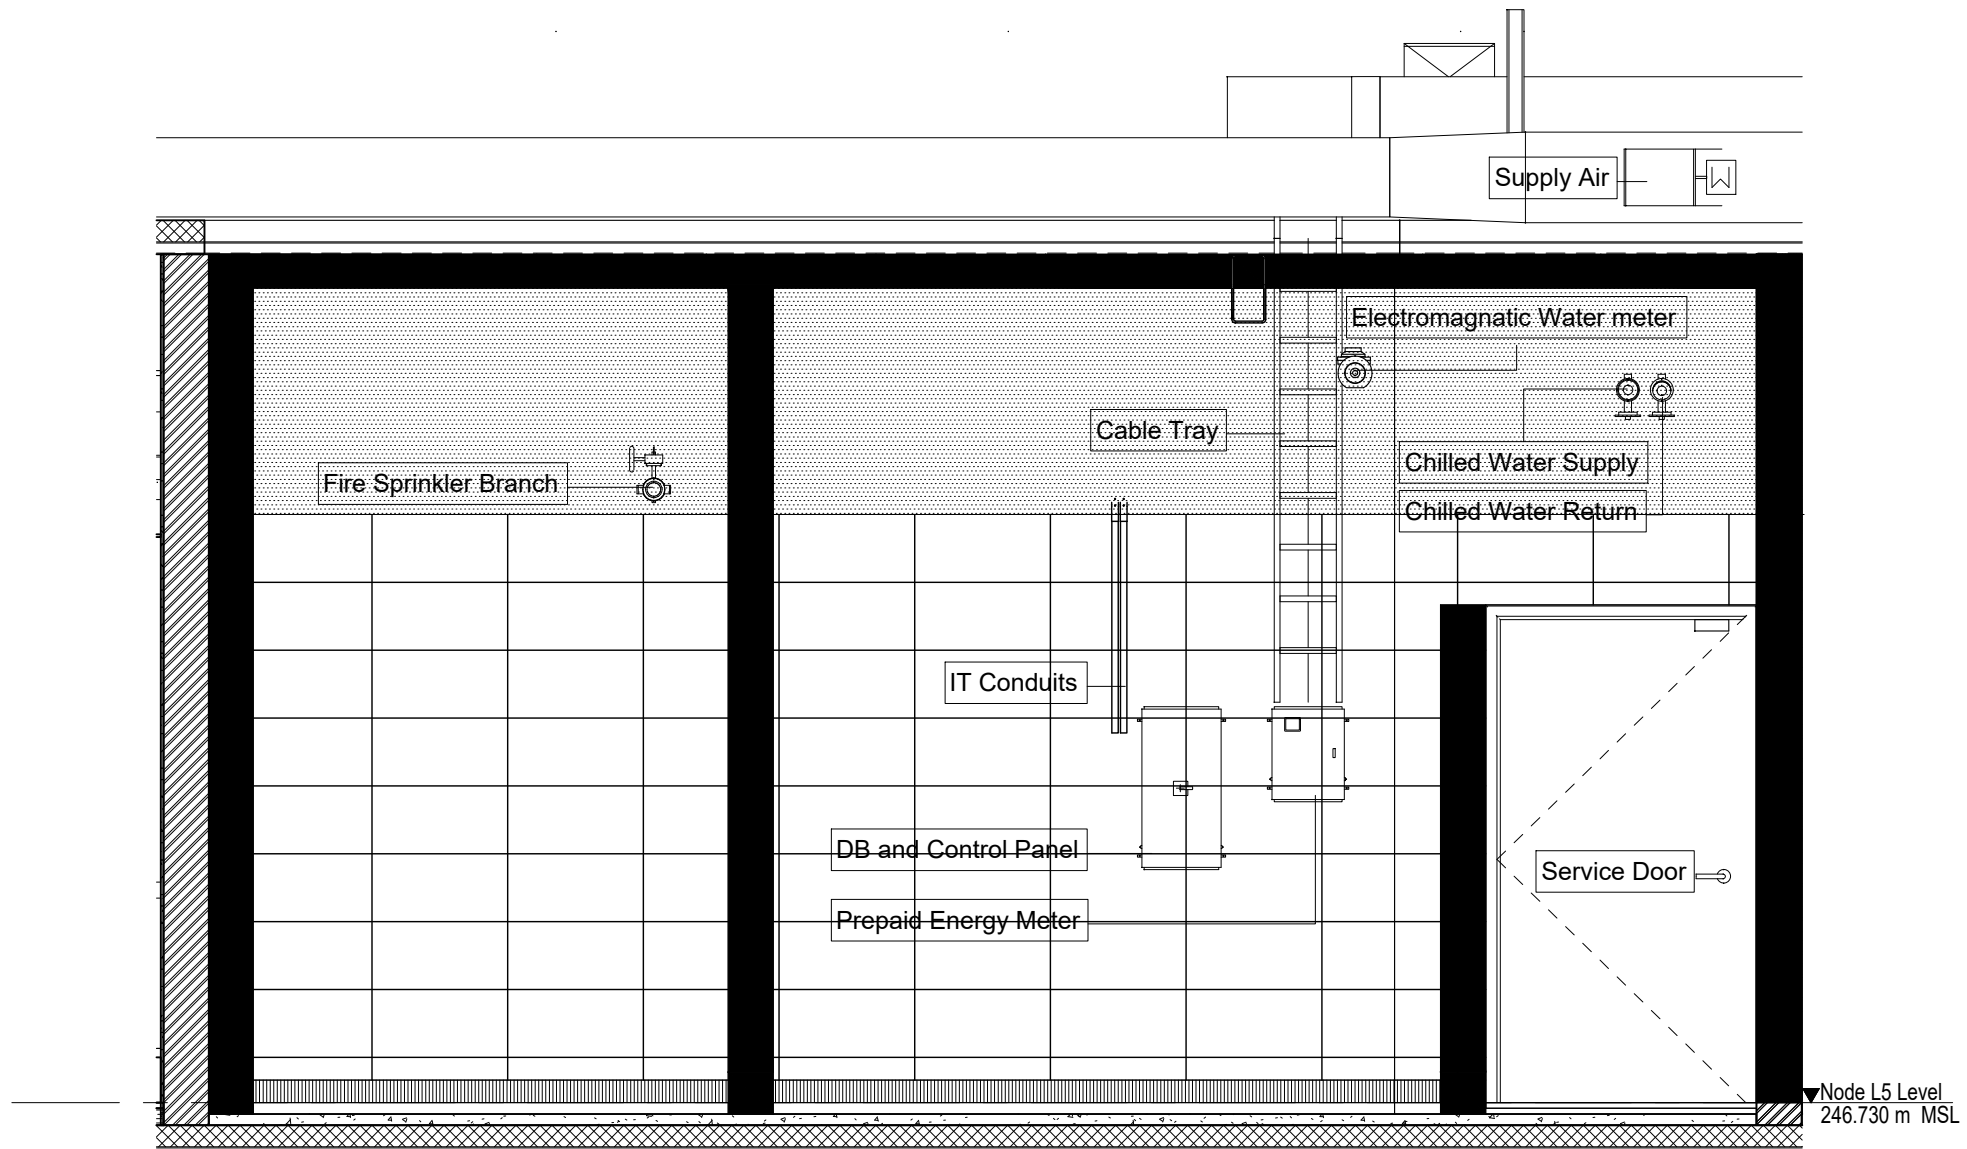

SECTION 'B'

 SCALE: NTS



Domino's
Pizza

JUBILANT FOODWORKS LTD.
(DOMINO'S PIZZA INDIA LTD.)
LOGIX TECHNO PARK, PLOT NO. 5,
TOWER - D, 5th FLOOR,
SECTOR - 127, NOIDA-201304,
PHONE: 0120-4090500, 4090594.

THESE PLANS & SPECIFICATIONS AS WELL AS DOMINO'S
NAME & LOGO TRADEMARKS & DESIGNS ARE THE EXCLUSIVE
PROPERTY OF JUBILANT COMPANY. ANY REPRODUCTION,
MODIFICATION, DISCLOSURE AND/OR USE OF THESE
MATERIALS (OR BY PORTION OF THEM) WITHOUT DOMINO'S
PRIOR WRITTEN CONSENT IS STRICTLY PROHIBITED.

DISCLAIMER-
IN CASE OF ANY SITE DISCREPANCY,
PLEASE GET BACK TO CORPORATE
DESIGN TEAM

JUBILANT FOODWORKS
INDIA LTD.

PROJ : GMR 1D DELHI
TOTAL AREA : 670 SQFT
KITCHEN AREA : 502 SQFT
BOH AREA : 178 SQFT
ZONE : NORTH
COUNTRY : INDIA.

RESTAURANT NO.:

DRAWN BY : VARUN

CHECKED BY :

ISSUED ON : 26-09-2023


REVISION NO.	REVISION DATE
1	11-10-2023
2	20-10-2023
3	27-10-2023
4	-2022

REMARKS : REVISED AS COMMENT

SCALE : NOT TO SCALE.

SHEET NO. : 20

SHEET TITLE : SECTION 'B'

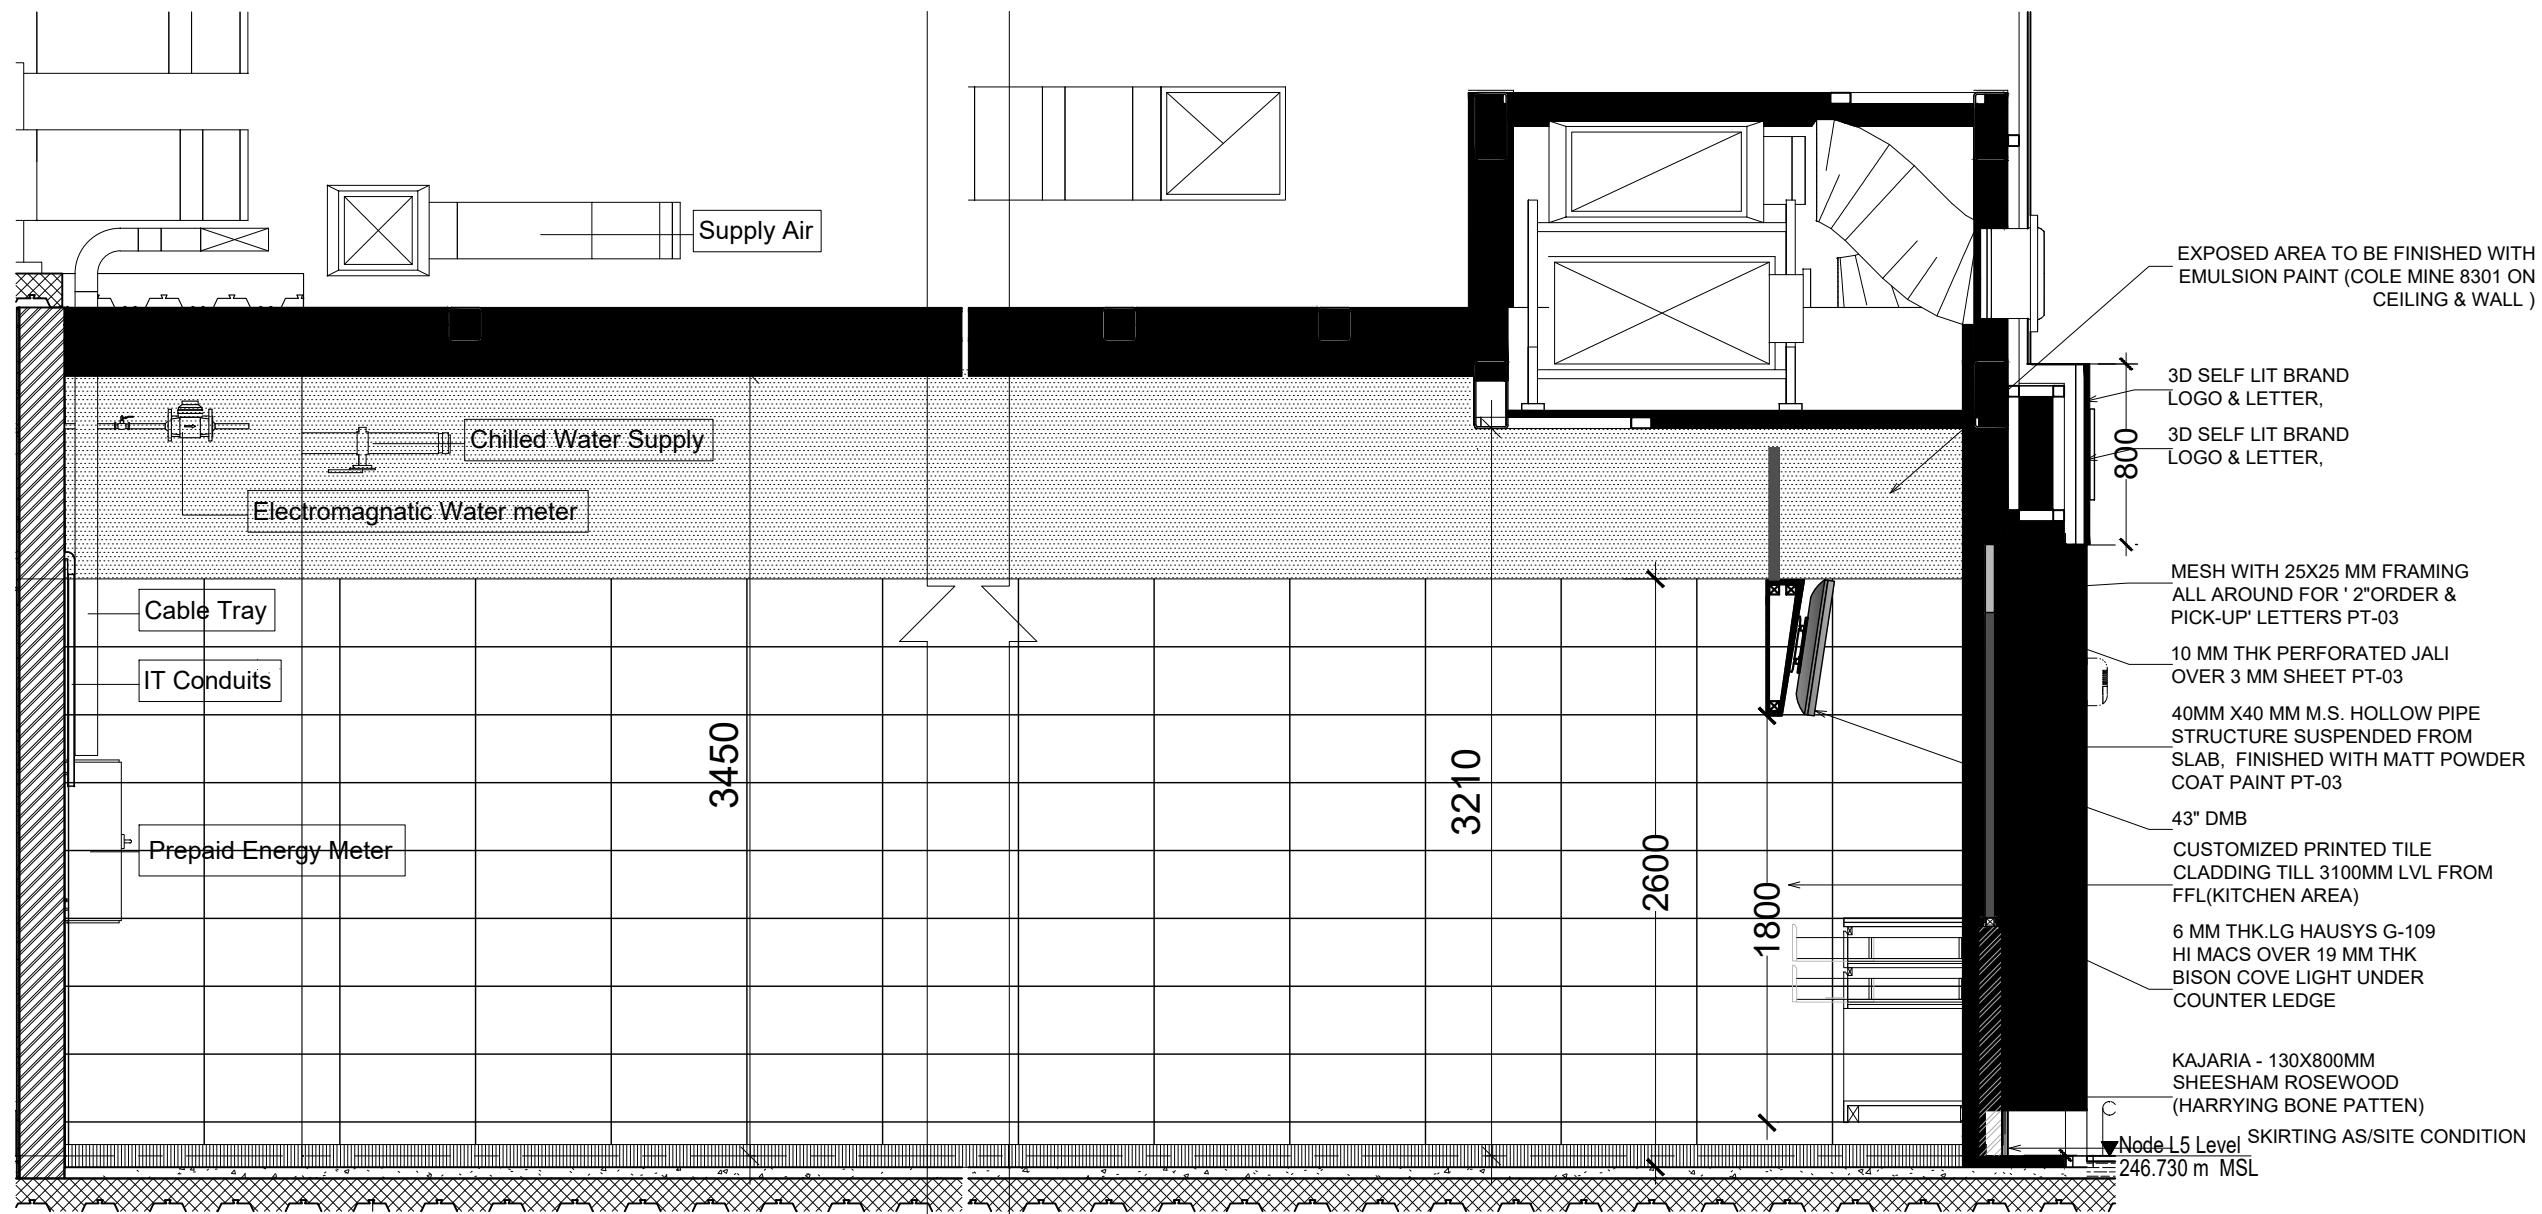

SECTION 'C'

SCALE: NTS

- EXPOSED AREA TO BE FINISHED WITH EMULSION PAINT (COLE MINE 8301 ON CEILING & WALL)
- 3D SELF LIT BRAND LOGO & LETTER,
- 3D SELF LIT BRAND LOGO & LETTER,
- 800
- MESH WITH 25X25 MM FRAMING ALL AROUND FOR ' 2"ORDER & PICK-UP' LETTERS PT-03
- 10 MM THK PERFORATED JALI OVER 3 MM SHEET PT-03
- 40MM X40 MM M.S. HOLLOW PIPE STRUCTURE SUSPENDED FROM SLAB, FINISHED WITH MATT POWDER COAT PAINT PT-03
- 43" DMB
- CUSTOMIZED PRINTED TILE CLADDING TILL 3100MM LVL FROM FFL(KITCHEN AREA)
- 6 MM THK.LG HAUSYS G-109 HI MACS OVER 19 MM THK BISON COVE LIGHT UNDER COUNTER LEDGE
- KAJARIA - 130X800MM SHEESHAM ROSEWOOD (HARRYING BONE PATTEN)
- Node L5 Level SKIRTING AS/SITE CONDITION 246.730 m MSL



**Domino's
Pizza**

JUBILANT FOODWORKS LTD.
(DOMINO'S PIZZA INDIA LTD.)
LOGIX TECHNO PARK, PLOT NO. 5,
TOWER - D, 5th FLOOR,
SECTOR - 127, NOIDA-201304.
PHONE: 0120-4090500, 4090594.

THESE PLANS & SPECIFICATIONS AS WELL AS DOMINO'S NAME & LOGO TRADEMARKS & DESIGNS ARE THE EXCLUSIVE PROPERTY OF JUBILANT COMPANY. ANY REPRODUCTION, MODIFICATION, DISCLOSURE AND/OR USE OF THESE MATERIALS (OR BY PORTION OF THEM) WITHOUT DOMINO'S PRIOR WRITTEN CONSENT IS STRICTLY PROHIBITED.

DISCLAIMER-
IN CASE OF ANY SITE DISCREPANCY, PLEASE GET BACK TO CORPORATE DESIGN TEAM

JUBILANT FOODWORKS INDIA LTD.

PROJ	: GMR 1D DELHI
TOTAL AREA	: 670 SQFT
KITCHEN AREA	: 502 SQFT
BOH AREA	: 178 SQFT
ZONE	: NORTH
COUNTRY	: INDIA.

RESTAURANT NO.:

DRAWN BY	: VARUN
CHECKED BY	:
ISSUED ON	: 26-09-2023






REVISION NO.	REVISION DATE
1	11-10-2023
2	20-10-2023
3	27-10-2023
4	-2022

REMARKS : REVISED AS/COMMENT

SCALE : NOT TO SCALE.

SHEET NO. : 21

 SHEET TITLE : SECTION 'C'

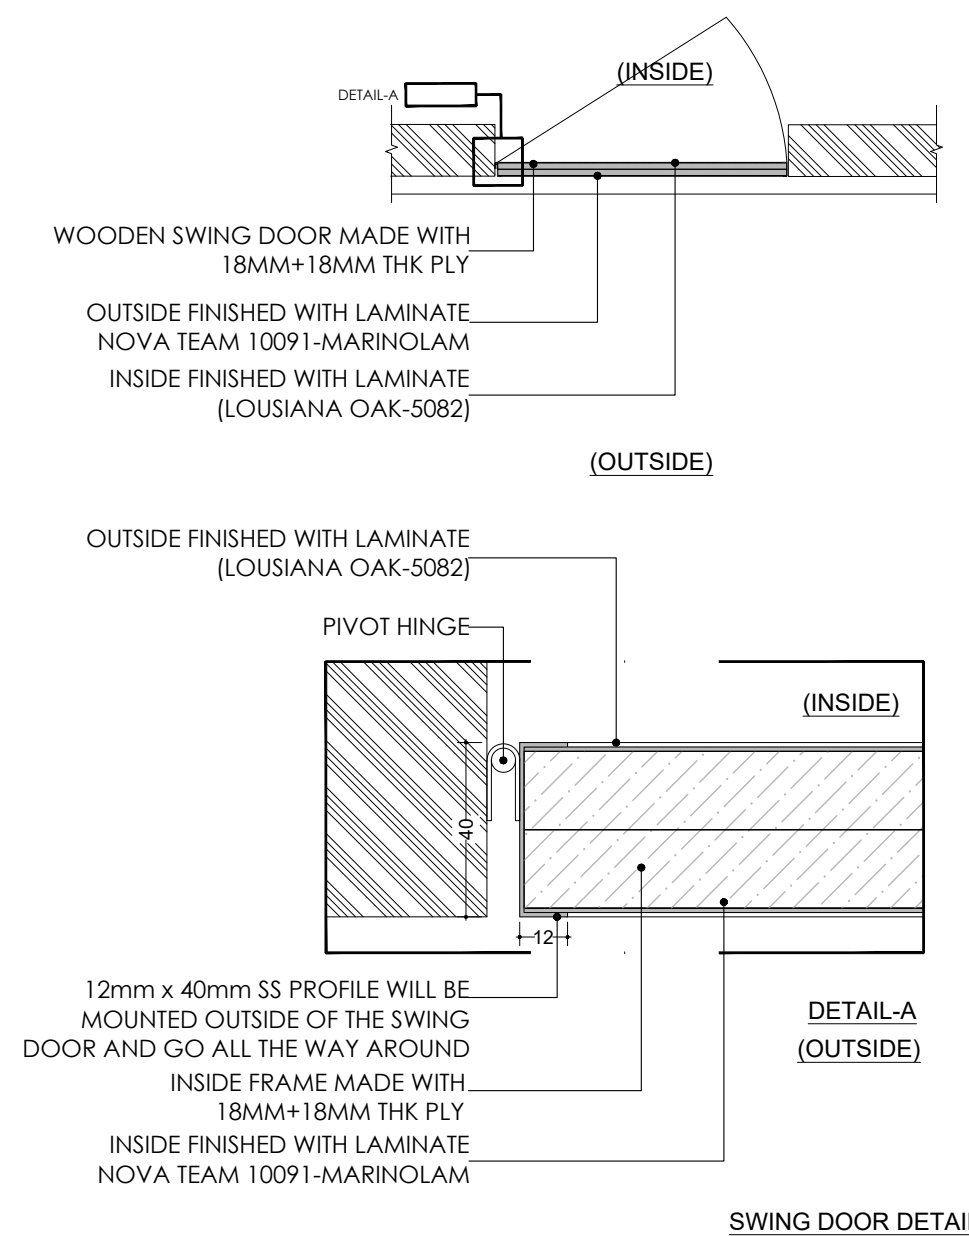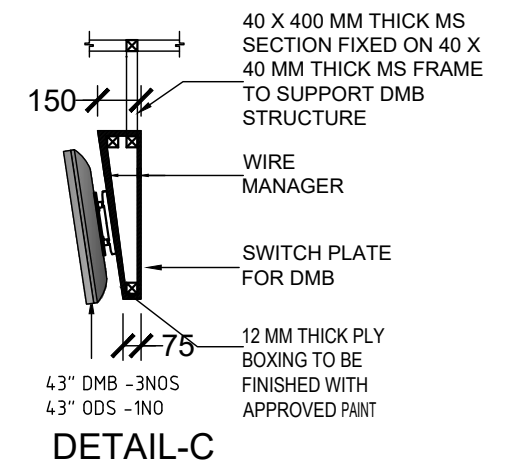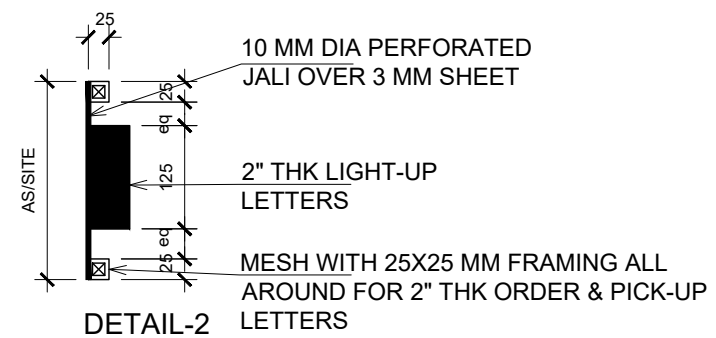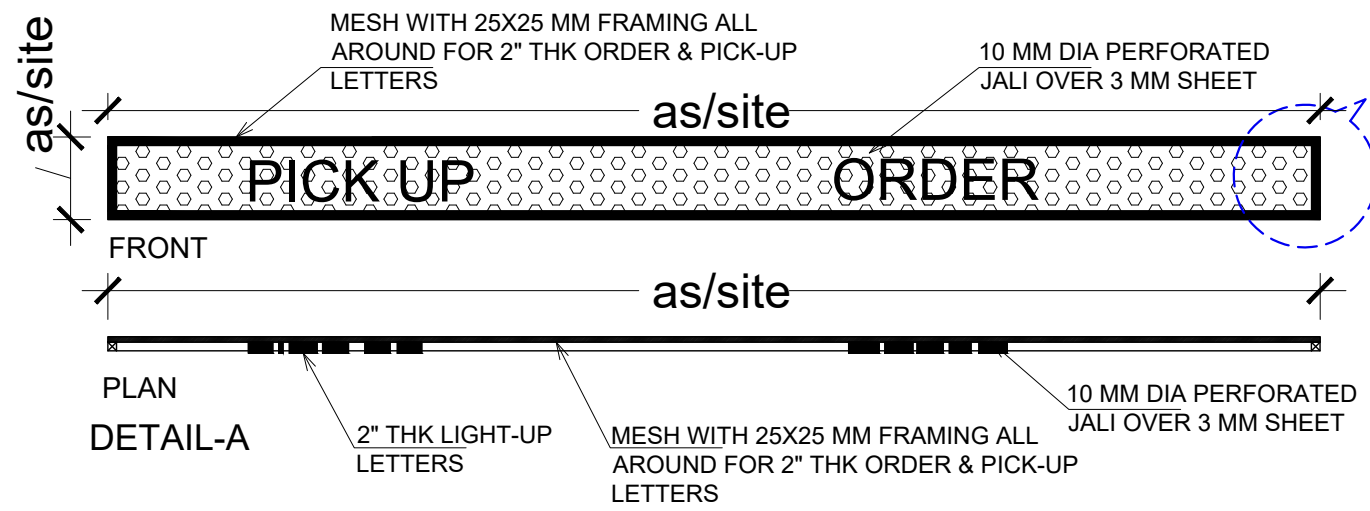**Domino's
Pizza**

JUBILANT FOODWORKS LTD.
(DOMINO'S PIZZA INDIA LTD.)
LOGIX TECHNO PARK, PLOT NO. 5,
TOWER - D, 5th FLOOR,
SECTOR - 127, NOIDA-201304,
PHONE: 0120-4090500, 4090594.

THESE PLANS & SPECIFICATIONS AS WELL AS DOMINO'S NAME & LOGO, TRADEMARKS & DESIGNS ARE THE EXCLUSIVE PROPERTY OF JUBILANT COMPANY. ANY REPRODUCTION, MODIFICATION, DISCLOSURE AND/OR USE OF THESE MATERIALS OR BY PORTION OF THEM WITHOUT DOMINO'S PRIOR WRITTEN CONSENT IS STRICTLY PROHIBITED.

DISCLAIMER-
IN CASE OF ANY SITE DISCREPANCY,
PLEASE GET BACK TO CORPORATE
DESIGN TEAM

JUBILANT FOODWORKS
INDIA LTD.

PROJ	: GMR 1D DELHI
TOTAL AREA	: 670 SQFT
KITCHEN AREA	: 502 SQFT
BOH AREA	: 178 SQFT
ZONE	: NORTH
COUNTRY	: INDIA.

RESTAURANT NO.:

DRAWN BY	: VARUN
CHECKED BY	:
ISSUED ON	: 26-09-2023
REVISION NO.	REVISION DATE
1	11-10-2023
2	20-10-2023
3	27-10-2023
4	-2022

REMARKS : REVISED AS COMMENT

SCALE : NOT TO SCALE.

SHEET NO. : 22

SHEET TITLE : DETAILS