




INHOUSE DESIGN

**GTB BAR  
@  
CHENNAI**

# DRY OUTLET

4938 [16'-6"]

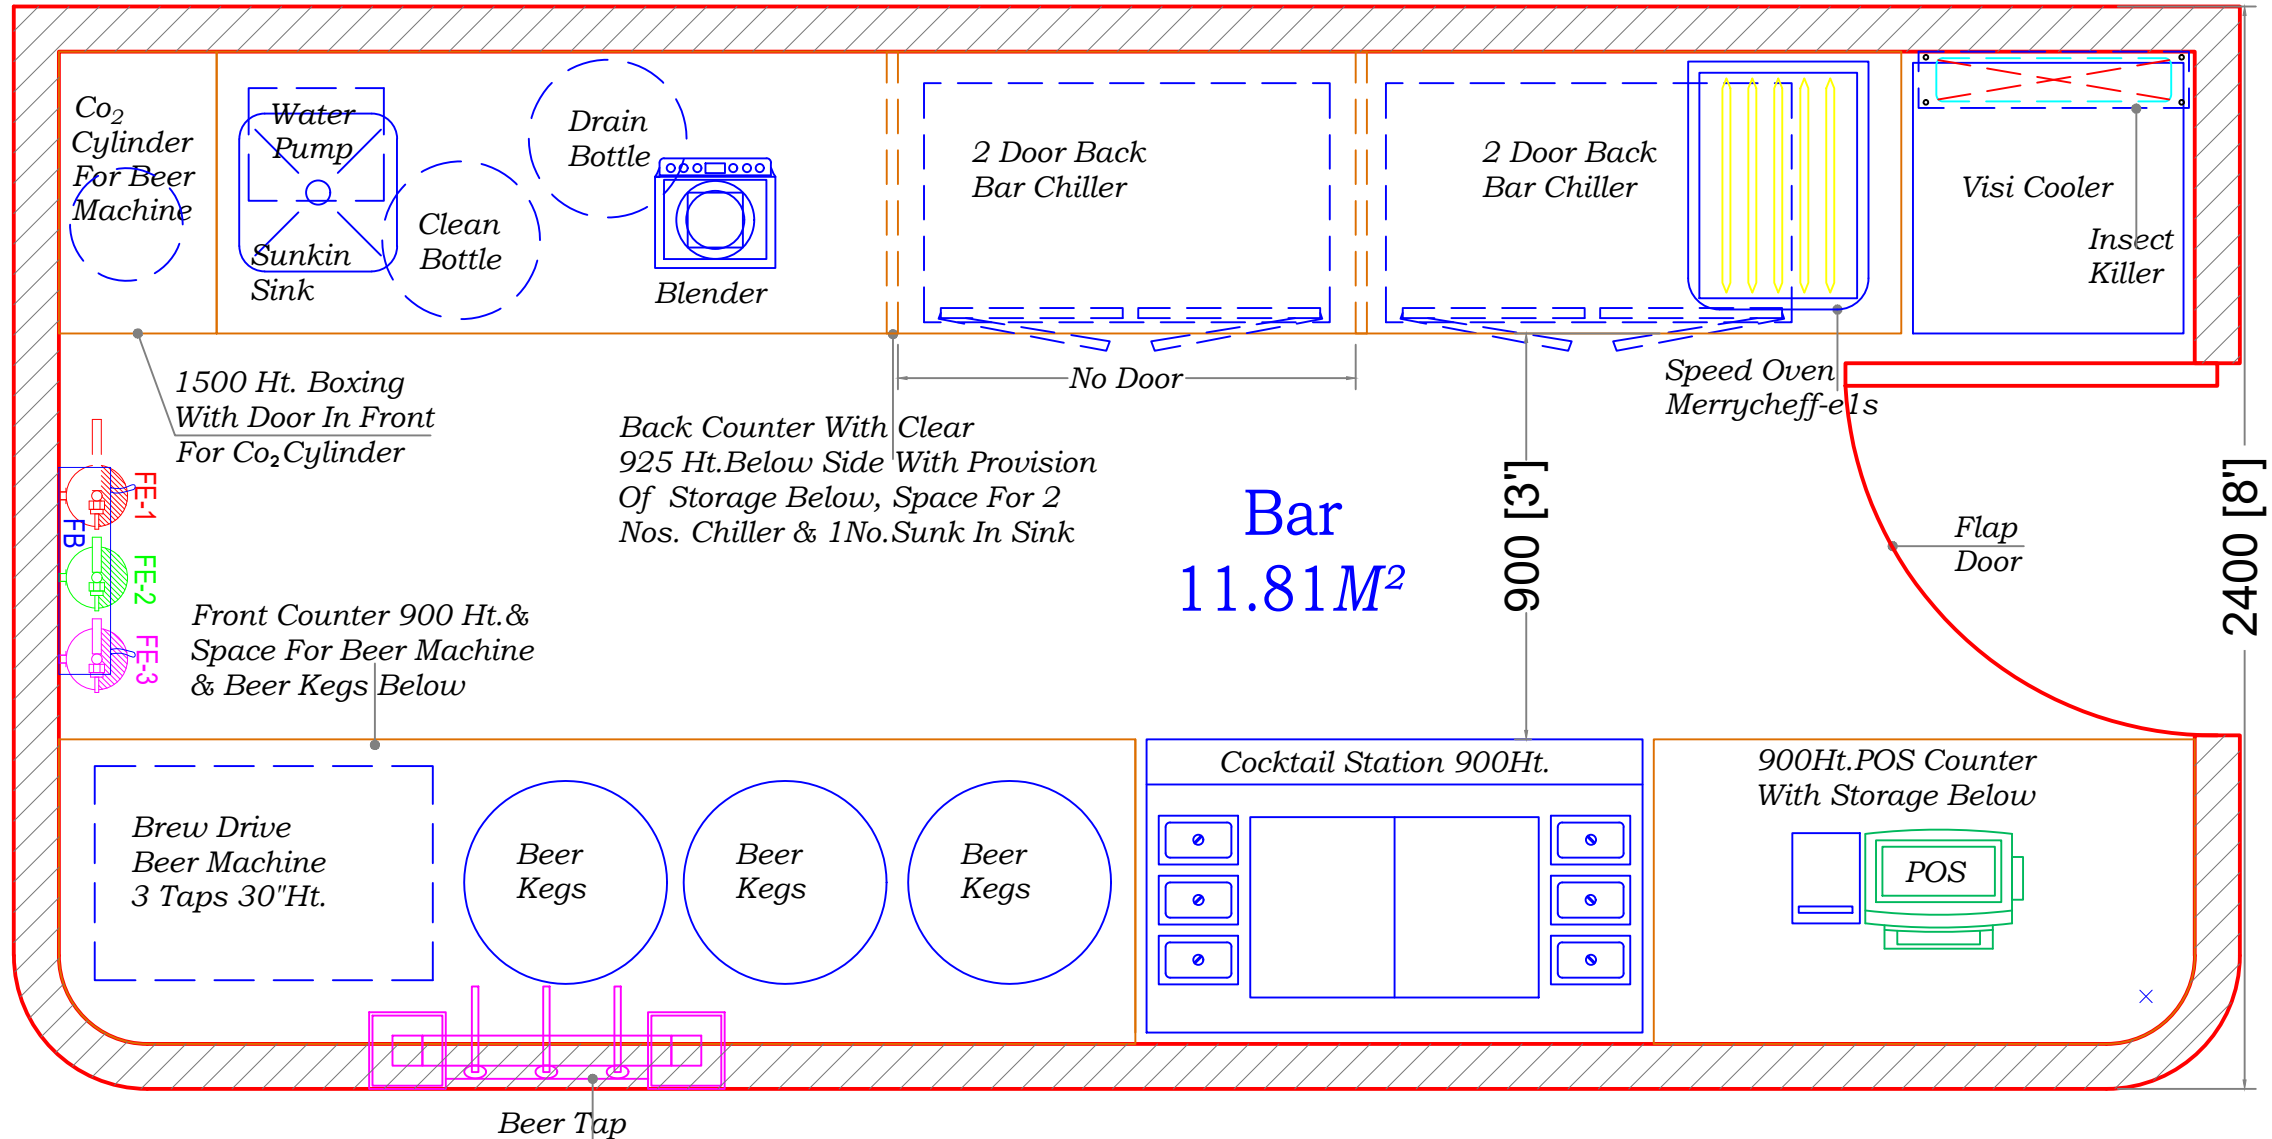

**Date - 23-01-24**

## T4 Terminal SHA Food Court-Chennai

SYMBOL	DESCRIPTION	QTY.
FE-1	Fire Extinguisher ABC-4Kg	01 Nos.
FE-2	Fire Extinguisher CO <sub>2</sub> -4.5Kg	01 Nos.
FE-3	Fire Extinguisher KType - 6Kg	01 Nos.
	Fire Blanket - 6' X 4'	01 Nos.


PROJECT	LOCATION	DRAWN BY	START DATE	CHK BY	DATE	REVISION No.	FINAL APPROVED	DRAWING	DRAWING NAME	SHEET NUMBER
GTB BAR	CHENNAI	SAEED	23-01-24			-				
		DWG.No.		SCALE		REVISION DATE :	DATE			
		----		NTS.		-	25-01-24		EQUIP NAMING LAYOUT	01 OF 03

# DRY OUTLET



INHOUSE DESIGN

**GTB BAR  
@  
CHENNAI**

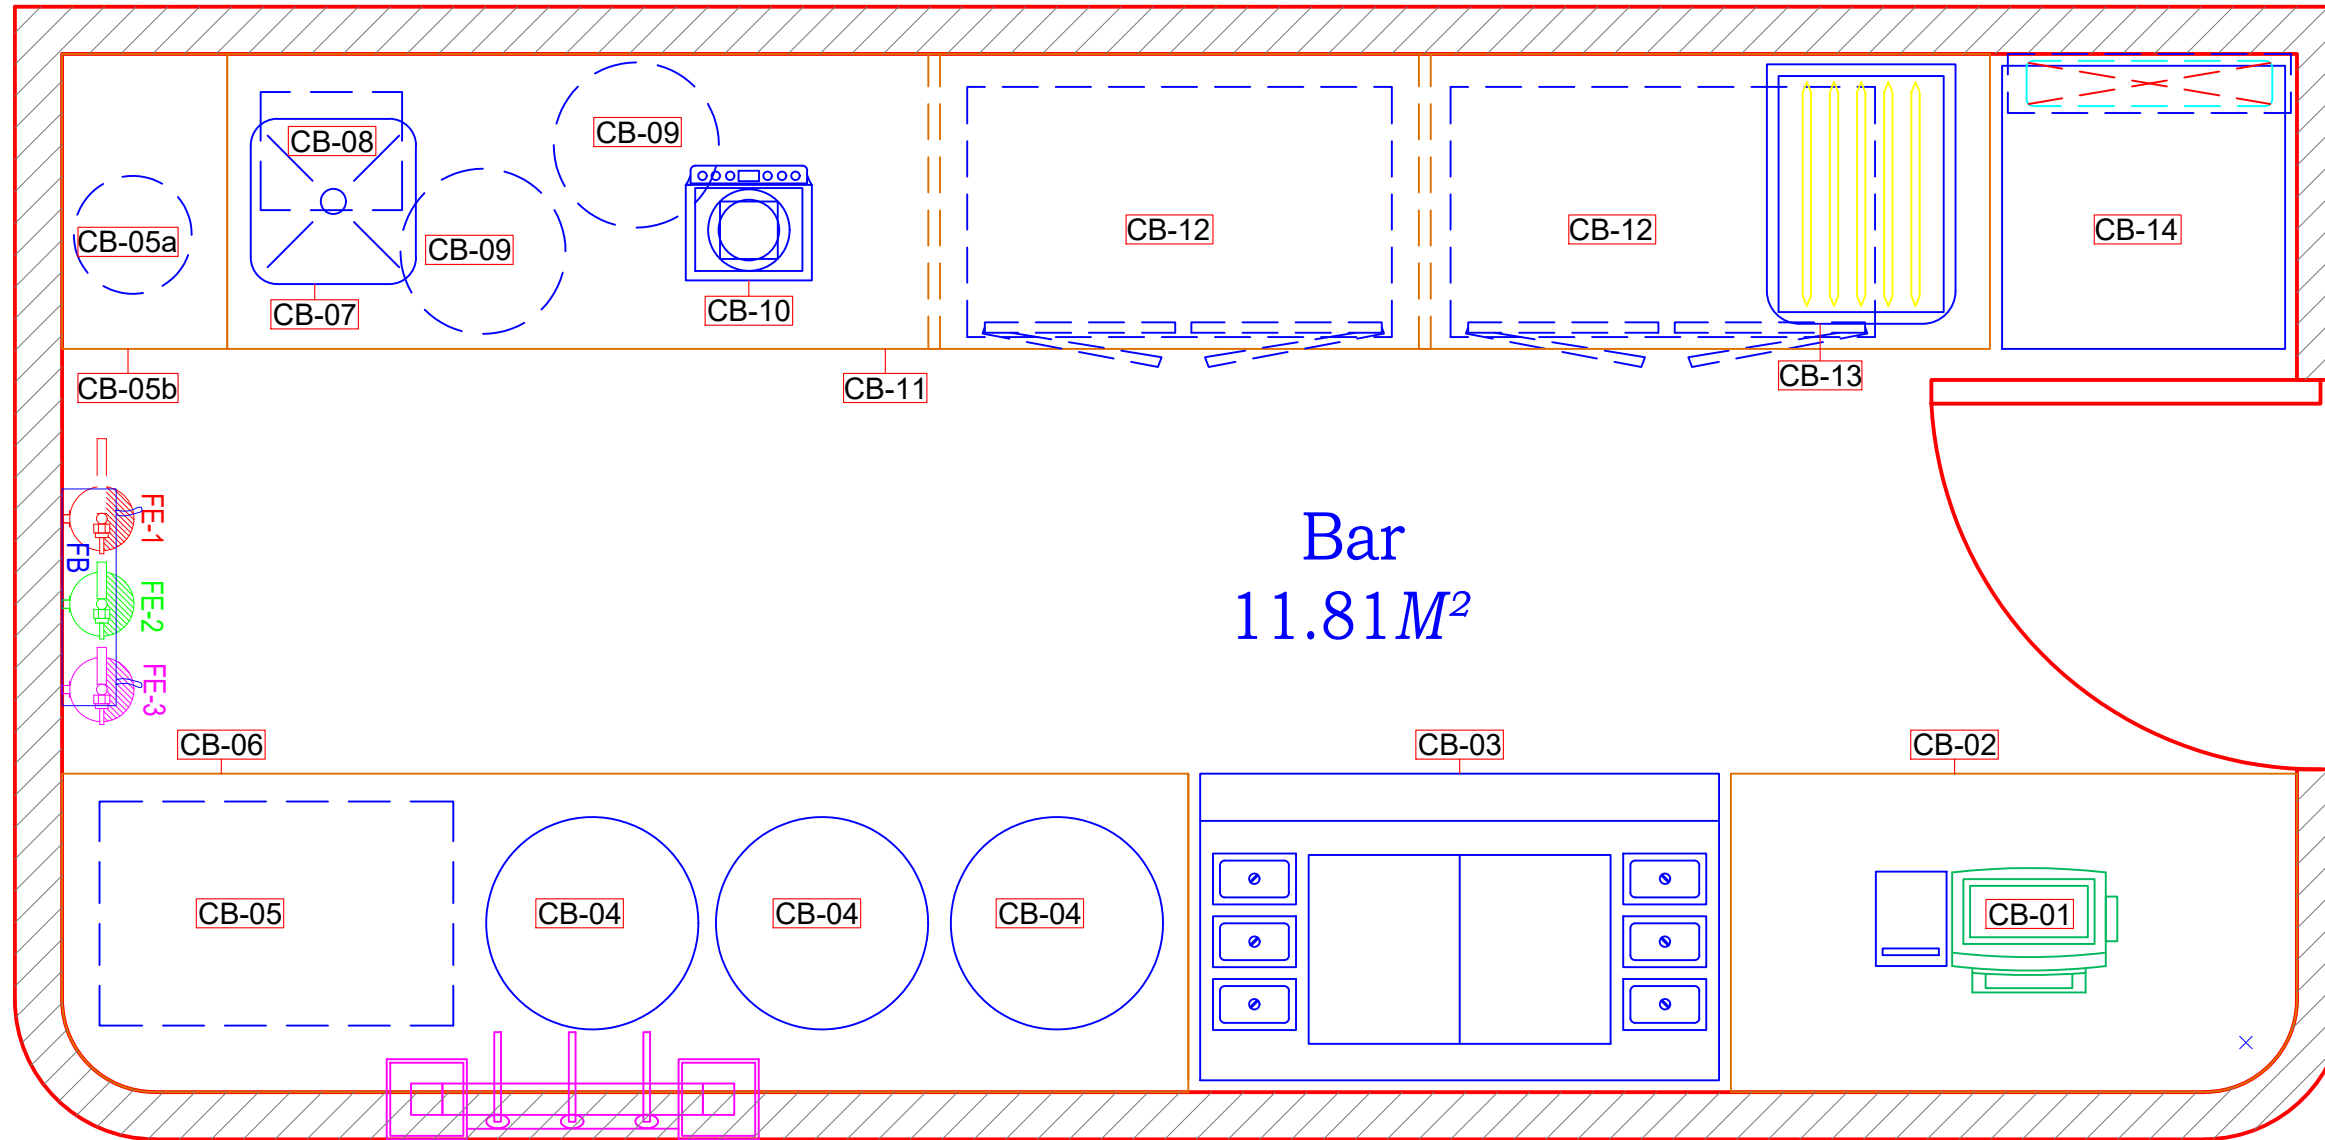

**Date - 23-01-24**

## T4 Terminal SHA Food Court-Chennai


PROJECT	LOCATION	DRAWN BY	START DATE	CHK BY	DATE	REVISION No.	FINAL APPROVED	DRAWING	DRAWING NAME	SHEET NUMBER
GTB BAR	CHENNAI	SAEED	23-01-24			-	DATE 25-01-24		EQUIP NUMBERING LAYOUT	02 OF 03
		DWG.No.		SCALE	REVISION DATE :					
		----		NTS.	-					

# DRY OUTLET



INHOUSE DESIGN

**GTB BAR  
@  
CHENNAI**

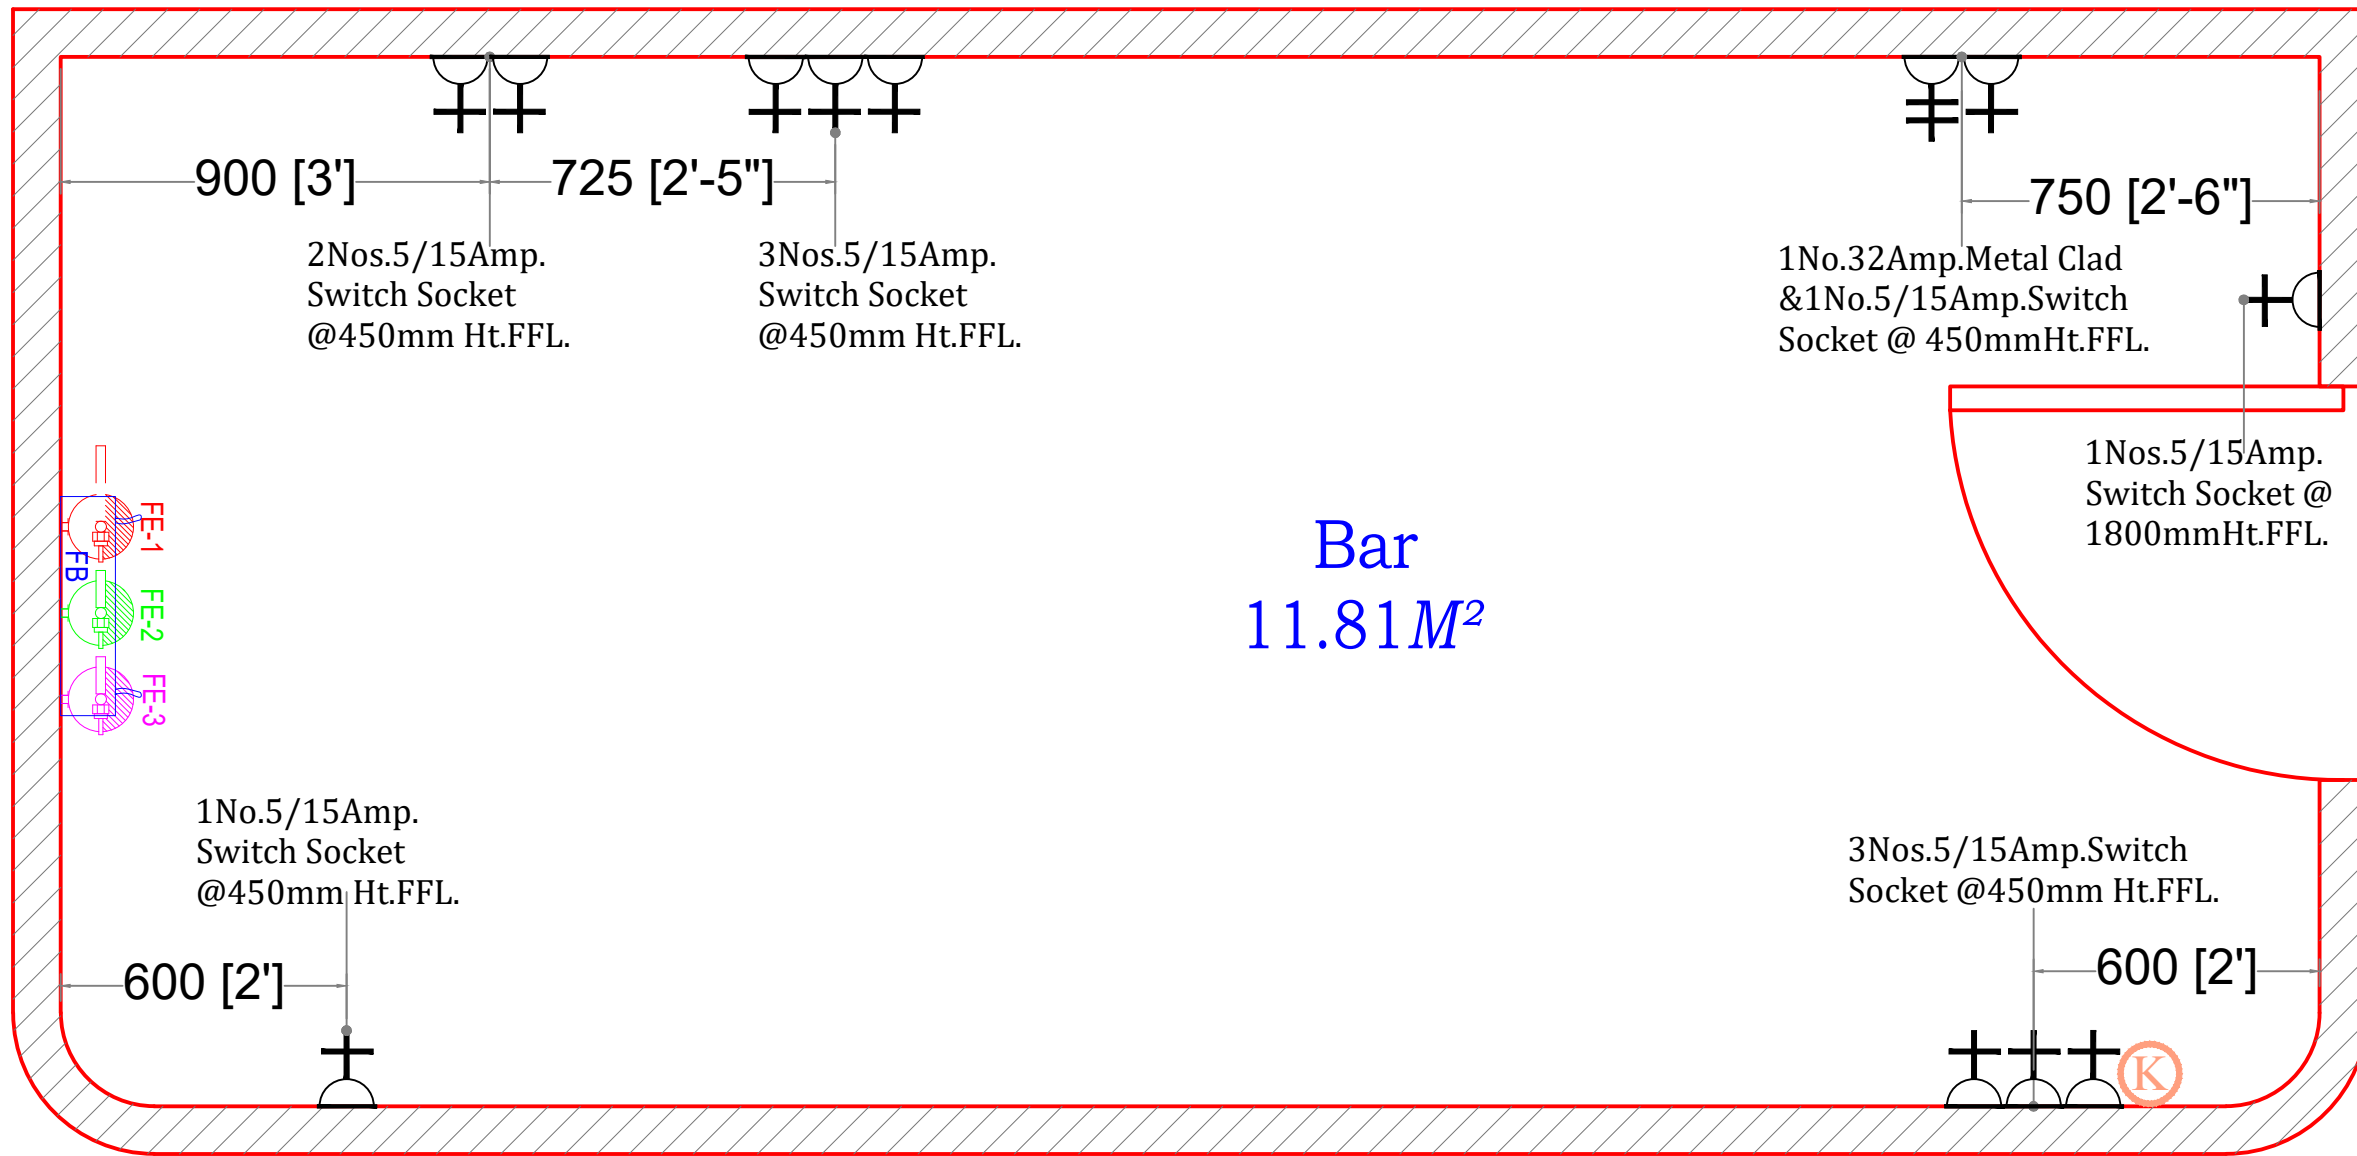

Bar  
11.81M<sup>2</sup>

Date - 23-01-24

ELECTRICAL LEGEND	
	5 AMP PLUG POINT
	5/15 AMP POWER PLUG POINT (MODULAR SWITCH & SOCKET)
	20/32 AMP METAL CLAD WITH 20 AMP SP MCB & PLUG TOP
	3 PHASE SUPPLY
	COMPUTER POINT
	TELEPHONE POINT
	DATA CABLE POINT FOR KOT PRINTER
	INTERNET

## T4 Terminal SHA Food Court-Chennai

PROJECT	LOCATION	DRAWN BY	START DATE	CHK BY	DATE	REVISION No.	FINAL APPROVED	DRAWING	DRAWING NAME		
GTB BAR	CHENNAI	SAEED	23-01-24			-					
		DWG.No.		SCALE		REVISION DATE :	DATE	25-01-24		ELECTRIC LAYOUT	03 OF 03
		----		NTS.		-					