

LEGEND				
SYMBOL	REF. IMAGES	QTY.	ARTICLE NO.	PRODUCT- DESCRIPTION
		09	36 W	PROFILE LIGHT FOR KITCHEN IN 6000 KELVIN-40 WATTS- WITH 3 PCB ROWS/REQ. LENGTH OF 1.2 MTRS IN SIZE OF 65X65MM OR 70X70MM IN MULTIPLES OF 8'12"/16" IN 10W/FT. FINISHED WITH BLACK POWDER COATING
		00		PROFILE LIGHT 20W ABOVE KITCHEN COUNTER IN 4000 KELVIN WITH PCB/REQ LENGTH OF 1.2 MTRS. IN SIZE OF 35X35MM IN MULTIPLE OF 8'12". FINISHED WITH BLACK POWDER COATING
		00		(LENGTH OF PROFILE = (0)) IN COUNTER COVE AREA
		01		AIR CURTAIN AS PER APPROVED 2NOS.
		TO BE CHECKED		CCTV CAMERA
		00	12W	CONCEALED PANEL LIGHT FOR TOILET IN 12 WATTS WITH 4000KELVIN. SIZE OF LIGHT TO BE 6" DIA. AND WHITE COLOUR FOR HAND WASH/WASH ROOM/CHANGE ROOM
		00	9 W	TRACK SPOT LIGHT 9 WATTS (WALL WASHER 24 DEGREE BEAM ANGLE)IN 4000 KELVIN TO HIGHLIGHT INTERNAL ARTICLAD & WALL GRAPHICS
		00	18 W	TRACK SPOT LIGHT 18 WATTS (WALL WASHER 45-60 DEGREE BEAM ANGLE)IN 4000KELVIN TO BE USED FOR DOUBLE HEIGHT STORES.
		00		1M TRACK
		00		2M TRACK (AT 22')
		AS PER SITE-05	9W	CONCEALED SPOT LIGHT IN 9 WATTS WITH IP65 RATING. SIZE OF LIGHT TO BE 3-4 INCHES DIA. WITH BEAM ANGLE 45DEG. LIGHT TO BE FINISH IN WHITE POWDER COATING AND 60DEG. FOR DOUBLE HT. STORES
		00		DECORATIVE DOME LIGHT @ HT OF 1950MM
		00		CUSTOMER AREA CONICAL DECORATIVE LIGHT AT HT OF 1950MM
		TO BE CHECKED		SPRINKLER
		TO BE CHECKED		SMOKE DETECTOR
		02		NORMAL T5 LIGHT
		01		PROFILE LIGHT 30W FOR RAFTERS IN 4000 KELVIN WITH PCB/REQ. LENGTH OF 1.2 MTRS. IN SIZE OF 70X50MM IN MULTIPLE OF 8'12". FINISHED WITH BLACK POWDER COATING
		09		DECO.PENDANT LIGHT FOR KITCHEN IN 6000KELVIN/LED BULB OF 6 WATTS IN 3"-4"HT.WITH B22 HOLDER.INDOOR FIXTURE
		00		CYLINDRICAL SURFACE MOUNTED LIGHT 20 WATT
		00		SURFACE MOUNTED SPEAKER
		00		WOOFER ABOVE 8'6"
		00		SPEAKER ABOVE 8'6"
		E		EMERGENCY LIGHT
		00		CYLINDER SURFACE MOUNTED LIGHT 9 WATT (AS/SITE CONDITION)
		00		CYLINDER SURFACE MOUNTED LIGHT 18 WATT (AS/SITE CONDITION)
		0		PROPOSED NEW 6 LIGHT WITH (AS/SITE CONDITION)
		0		PROPOSED NEW CLUSTER OF LIGHTS

CARPET AREA - 500 SQ.FT.

KITCHEN AREA - 378 SQFT.

BOH AREA - 122 SQFT.

SLAB BOTTOM - 3680MM

BEAM BOTTOM - 3238MM

NOTES

- 1.ALL DIMENSIONS ARE IN MM.
- 2.ALL LEVELS INDICATED ARE IN MM.
- 3.DIMENSIONS / LEVELS INDICATED ARE STRUCTURAL UNLESS OTHER SPECIFIED.
- 4.THIS DRAWING, UNLESS OTHERWISE MENTIONED, TO BE PLOTTED TO STANDARD A1 SIZE.
- 5.ONLY WRITTEN DIMENSIONS TO BE FOLLOWED.DO NOT SCALE THE DRAWING
- 6.DIMENSIONS / LEVELS SHOWN TO BE VERIFIED AT SITE BEFORE COMMENCEMENT OF WORK ANY DISCREPANCIES IF NOTED,SHOULD BE BROUGHT TO THE NOTICE OF ARCHITECT.PRIOR TO COMMENCEMENT OF WORK.
- 7.RELEVANT SERVICES DRAWINGS ARE TO BE READ SIMULTANEOUSLY AND PROVISION OF CUTOUTS/SLEEVES TO BE PROVIDED AS REQUIRED.
- 8.ALL MATERIALS / FINISHES TO BE AS SPECIFIED AND APPROVED BY THE CONSULTANTS.

CLIENT:

PURPOSE OF RELEASE
AAMIR

MEP CONSULTANTS:
CRESCENT ENGINEERS

PROJECT
KHALGHAT - MP


ARCHITECTS & INTERIOR SCENARIES
2209, KALPITA ENCLAVE, 80 N. ROAD, ANDHERI-EST,
MUMBAI-400 082 TEL: +91 22 394 2103

DWG NO. 142-24 / 112 R0

DRAWING: LIGHTING LINEOUT PLAN 00

DRAWN BY: SAJJAD CHKD BY: AAMIR SCALE: 1:50 DATE: 05/03/2024


THIS DRAWING IS THE SOLE PROPERTY OF STUDIO SQUARE IT'S USE FOR ANY PURPOSE OTHER THAN THAT MENTIONED IS TO BE DONE ONLY AFTER PRIOR APPROVAL.

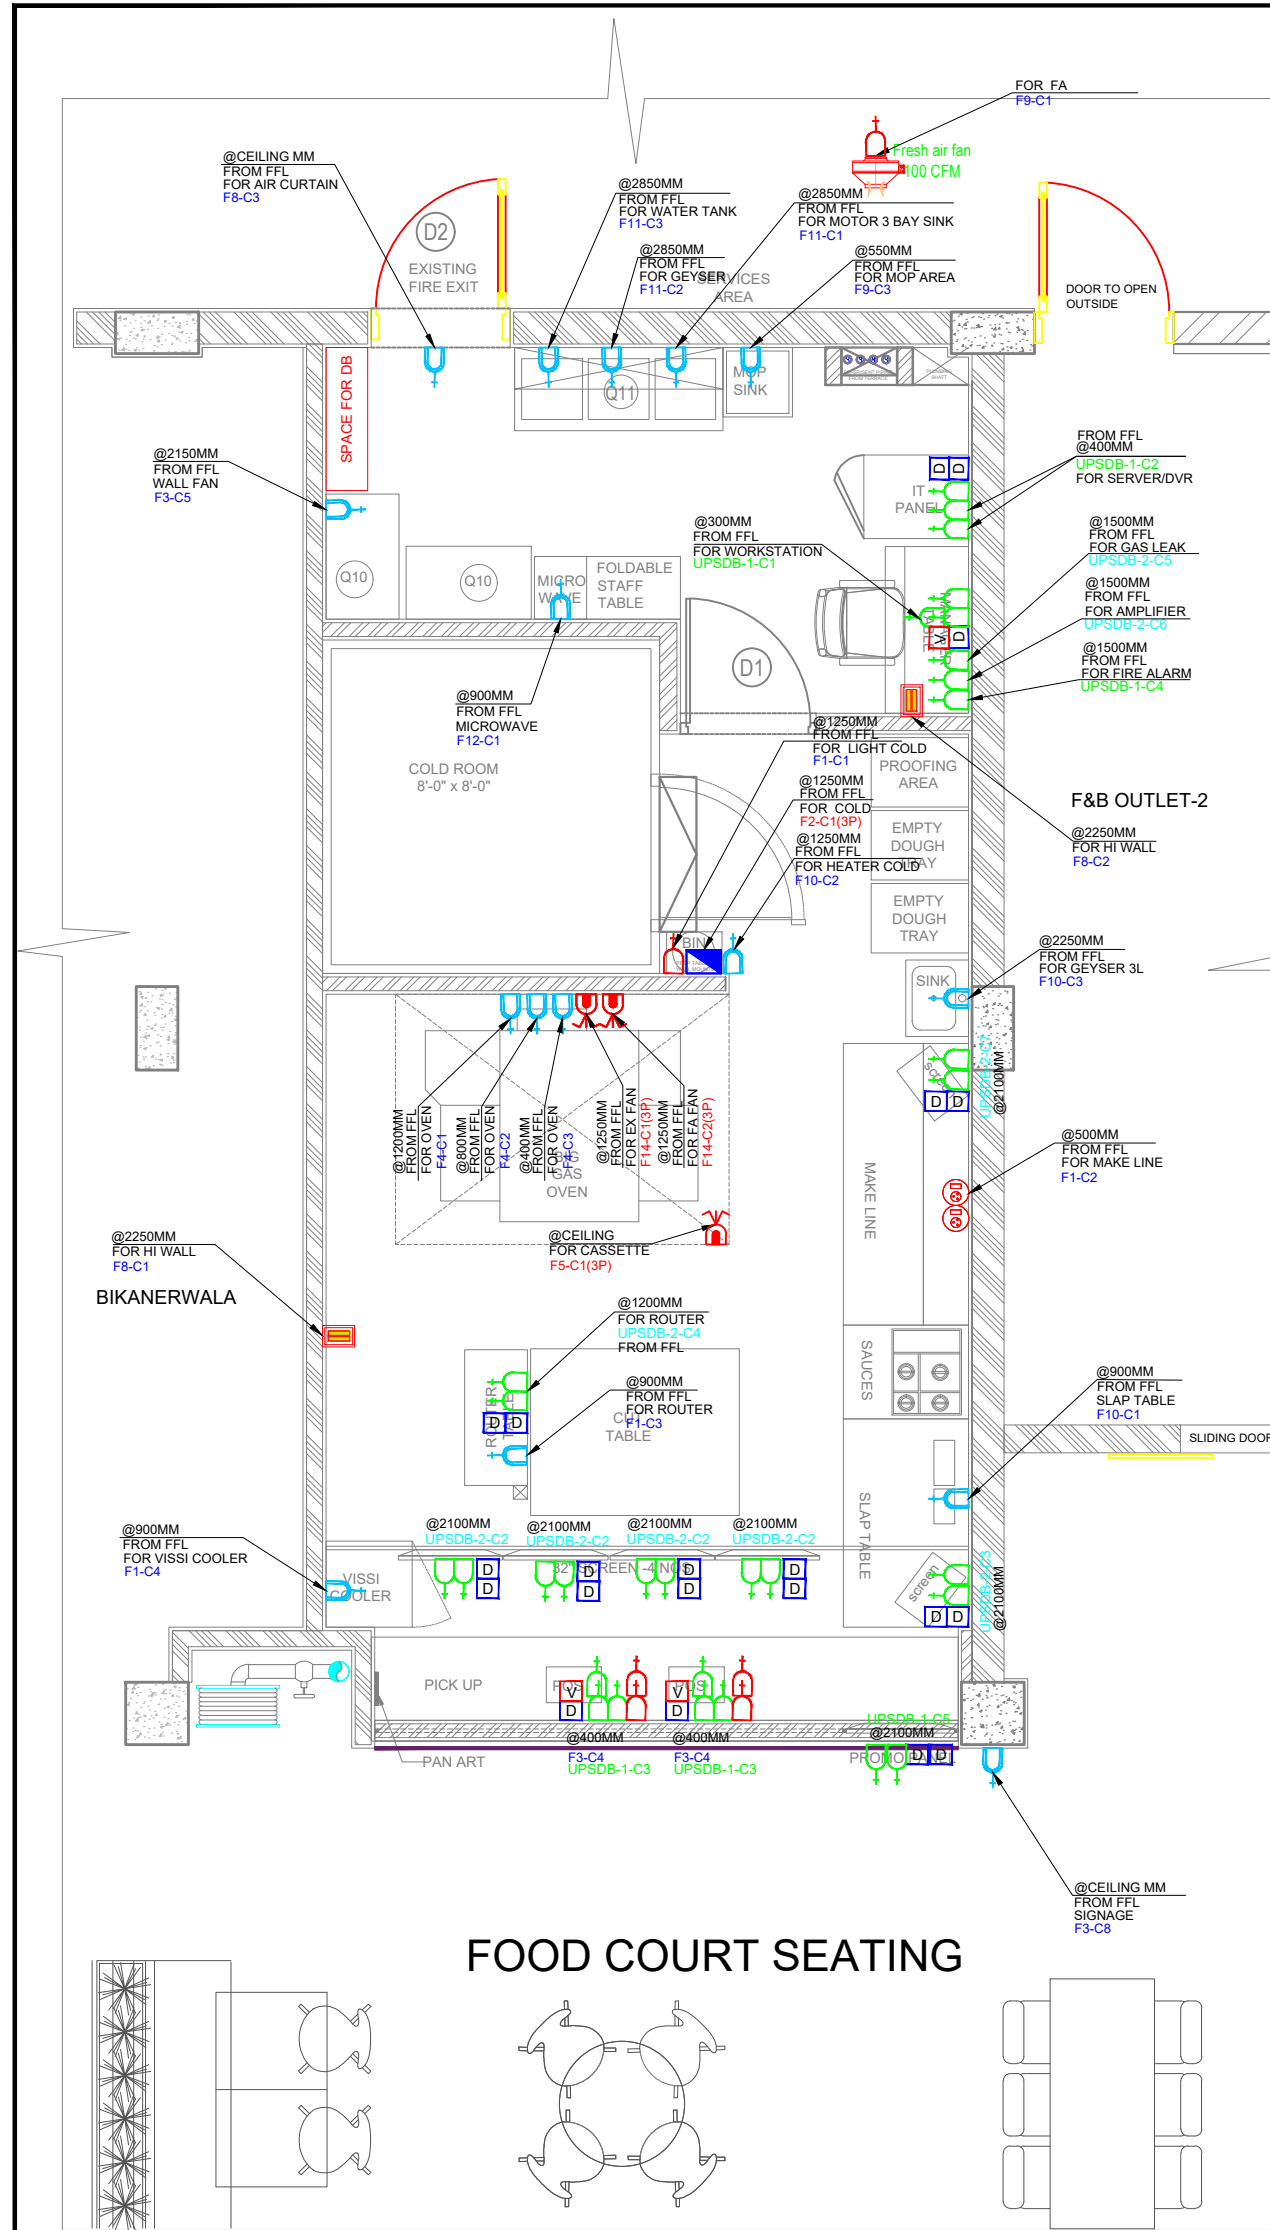

LEGEND:- POWER

SYMBOL	DESCRIPTION
	6A SOCKET WITH SWITCH(RAW)
	6/16A SOCKET WITH SWITCH (RAW)
	6A SOCKET WITH SWITCH(UPS)
	6/16A SOCKET WITH SWITCH(UPS)
	25A SWITCH & SOCKET(230V,1PH.SUPPLY)
	25A INDUSTRIAL SOCKET(1PH)
	25A ISOLATOR
	POP UP BOX 1NOS 6 A SWITCH SOCKET
	16A ISOLATOR WITH W/P ENCLOSURE (3PH)
	DATA POINT
	VOICE POINT

FOOD COURT SEATING

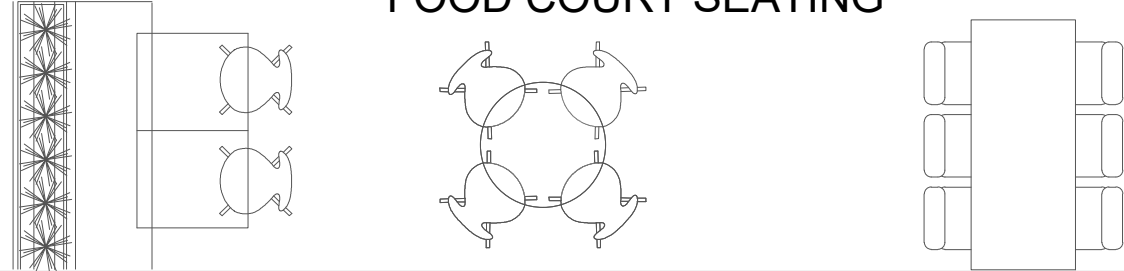

CARPET AREA - 500 SQ.FT.
 KITCHEN AREA - 378 SQFT.
 BOH AREA - 122 SQFT.
 SLAB BOTTOM - 3680MM
 BEAM BOTTOM - 3238MM

NOTES

- 1.ALL DIMENSIONS ARE IN MM.
- 2.ALL LEVELS INDICATED ARE IN MM.
- 3.DIMENSIONS / LEVELS INDICATED ARE STRUCTURAL UNLESS OTHER SPECIFIED.
- 4.THIS DRAWING, UNLESS OTHERWISE MENTIONED, TO BE PLOTTED TO STANDARD A1 SIZE.
- 5.ONLY WRITTEN DIMENSIONS TO BE FOLLOWED.DO NOT SCALE THE DRAWING
- 6.DIMENSIONS / LEVELS SHOWN TO BE VERIFIED AT SITE BEFORE COMMENCEMENT OF WORK ANY DISCREPANCIES IF NOTED,SHOULD BE BROUGHT TO THE NOTICE OF ARCHITECT.PRIOR TO COMMENCEMENT OF WORK.
- 7.RELEVANT SERVICES DRAWINGS ARE TO BE READ SIMULTANEOUSLY AND PROVISION OF CUTOUTS/SLEEVES TO BE PROVIDED AS REQUIRED.
- 8.ALL MATERIALS / FINISHES TO BE AS SPECIFIED AND APPROVED BY THE CONSULTANTS.

CLIENT:


PURPOSE OF RELEASE
 RINK MALL-DARJEELING

MEP CONSULTANTS:
 CRESCENT ENGINEERS

PROJECT
 KHALGHAT - MP

DWG NO.	142-24 / 166	R0	00
DRAWING:	POWER PLAN		
DRAWN BY:	CHKD BY:	SCALE:	DATE:
SAJJAD	AAMIR	1:50	05/03/2024


THIS DRAWING IS THE SOLE PROPERTY OF STUDIO SQUARE IT'S USE FOR ANY PURPOSE OTHER THAN THAT MENTIONED IS TO BE DONE ONLY AFTER PRIOR APPROVAL.

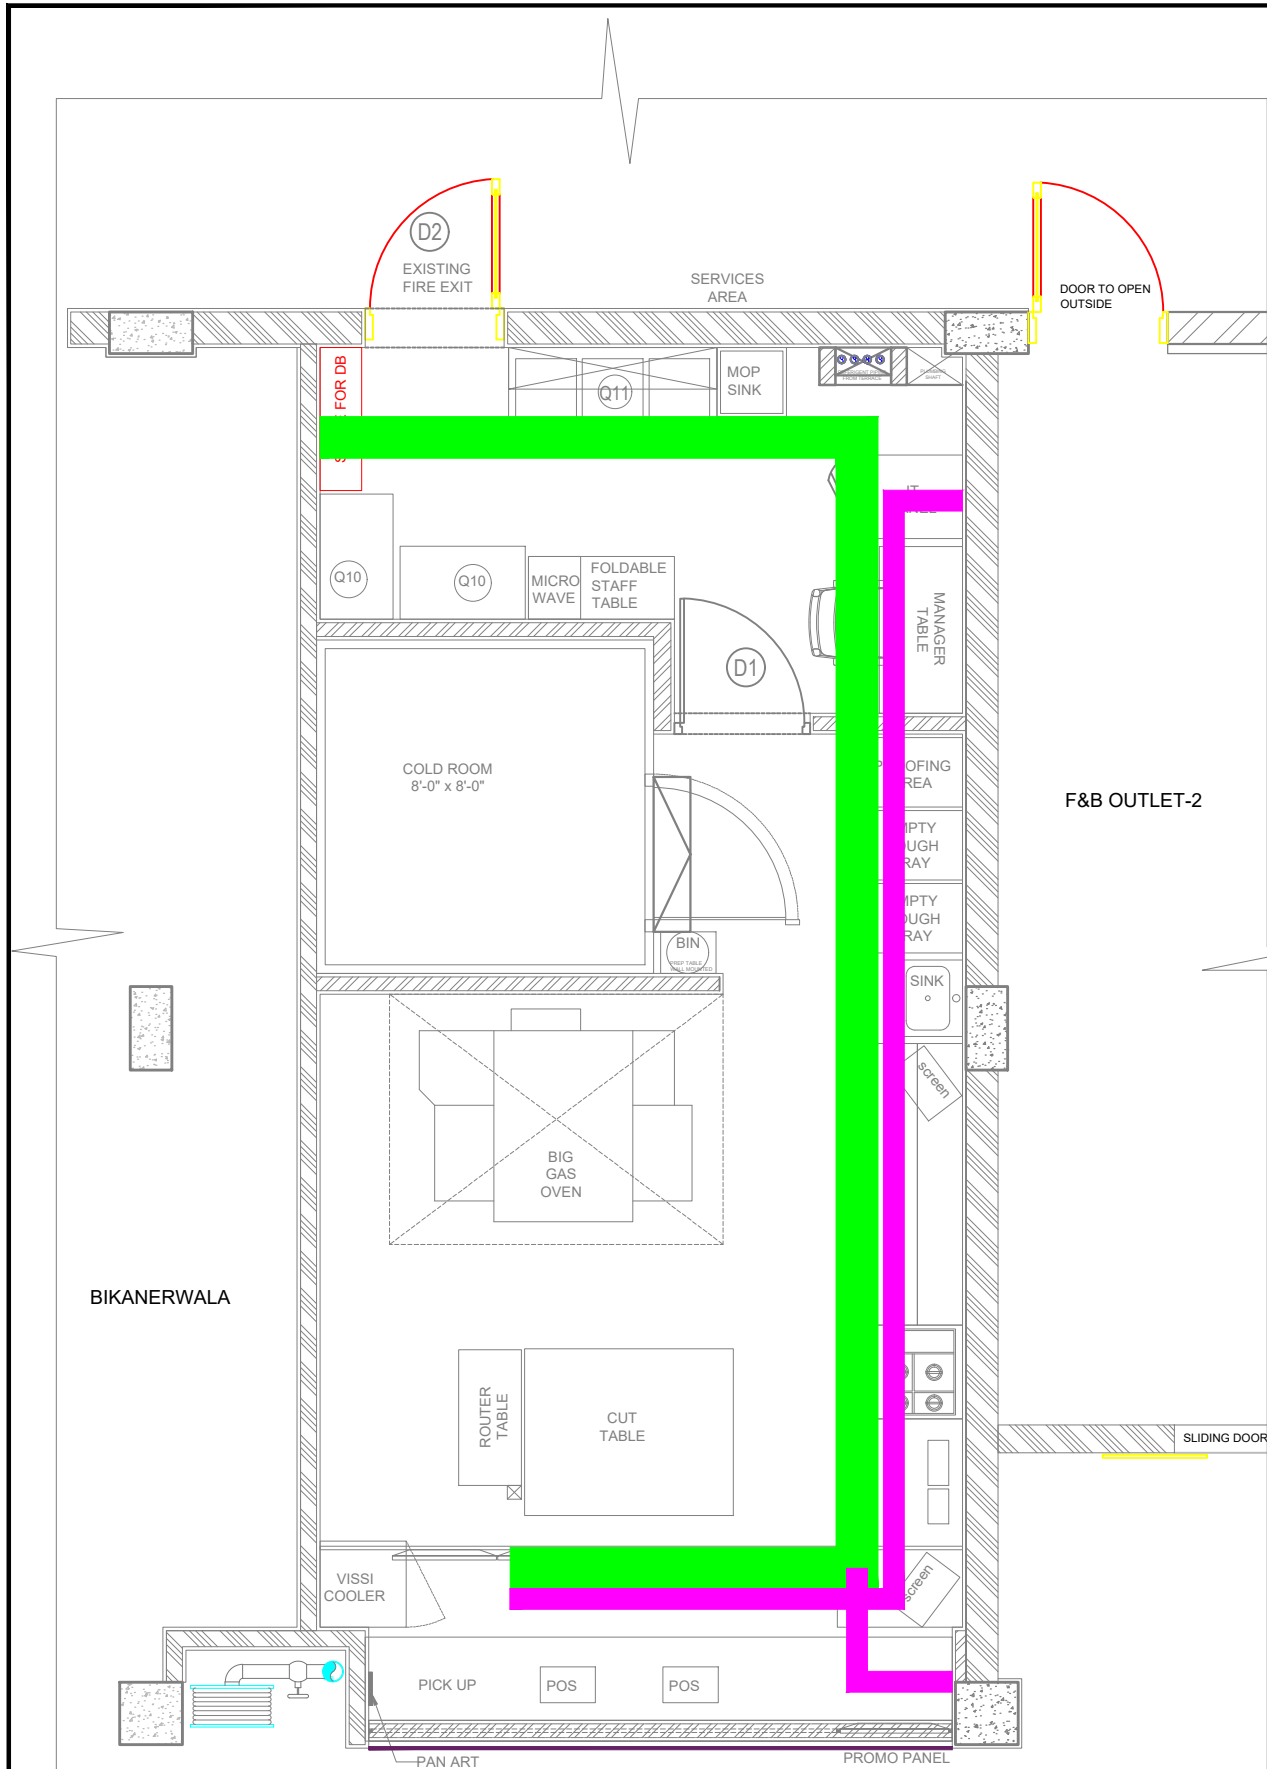

LEGEND	
	300mmx 50mm GI Trunking - Power
	50mmx 50mm GI Trunking - Power/Data
	150mmx 50mm GI Trunking - Lighting/AC

BIKANERWALA

FOOD COURT SEATING

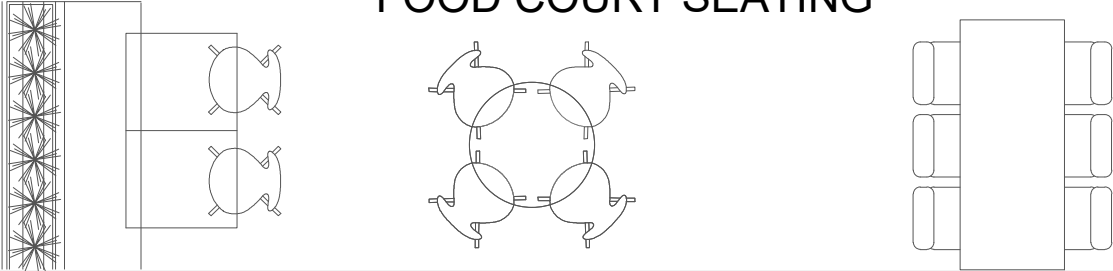

CARPET AREA - 500 SQ.FT.	
KITCHEN AREA	- 378 SQFT.
BOH AREA	- 122 SQFT.
SLAB BOTTOM - 3680MM	
BEAM BOTTOM - 3238MM	

NOTES

1. ALL DIMENSIONS ARE IN MM.
2. ALL LEVELS INDICATED ARE IN MM.
3. DIMENSIONS / LEVELS INDICATED ARE STRUCTURAL UNLESS OTHERWISE SPECIFIED.
4. THIS DRAWING, UNLESS OTHERWISE MENTIONED, TO BE PLOTTED TO STANDARD A1 SIZE.
5. ONLY WRITTEN DIMENSIONS TO BE FOLLOWED. DO NOT SCALE THE DRAWING.
6. DIMENSIONS / LEVELS SHOWN TO BE VERIFIED AT SITE BEFORE COMMENCEMENT OF WORK ANY DISCREPANCIES IF NOTED, SHOULD BE BROUGHT TO THE NOTICE OF ARCHITECT PRIOR TO COMMENCEMENT OF WORK.
7. RELEVANT SERVICES DRAWINGS ARE TO BE READ SIMULTANEOUSLY AND PROVISION OF CUTOUTS/SLEEVES TO BE PROVIDED AS REQUIRED.
8. ALL MATERIALS / FINISHES TO BE AS SPECIFIED AND APPROVED BY THE CONSULTANTS.

CLIENT:

Domino's


PURPOSE OF RELEASE
RINK MALL-DARJEELING

MEP CONSULTANTS:
CRESCENT ENGINEERS

PROJECT
KHALGHAT - MP

STUDIOSQUARE
ARCHITECTS & INTERIOR DESIGNERS
23/08, KALIPETA ENCLAVE, 8th ROAD, ANDHERI-EST,
MUMBAI-400 087 TEL: +91 22 394 2193

DWG NO.	142-24 / 167	R0	00
DRAWING:	CABLE TRAY PLAN		
DRAWN BY:	CHKD BY:	SCALE:	DATE:
SAJJAD	AAMIR	1:50	05/03/2024
THIS DRAWING IS THE SOLE PROPERTY OF STUDIO SQUARE IT'S USE FOR ANY PURPOSE OTHER THAN THAT MENTIONED IS TO BE DONE ONLY AFTER PRIOR APPROVAL.			

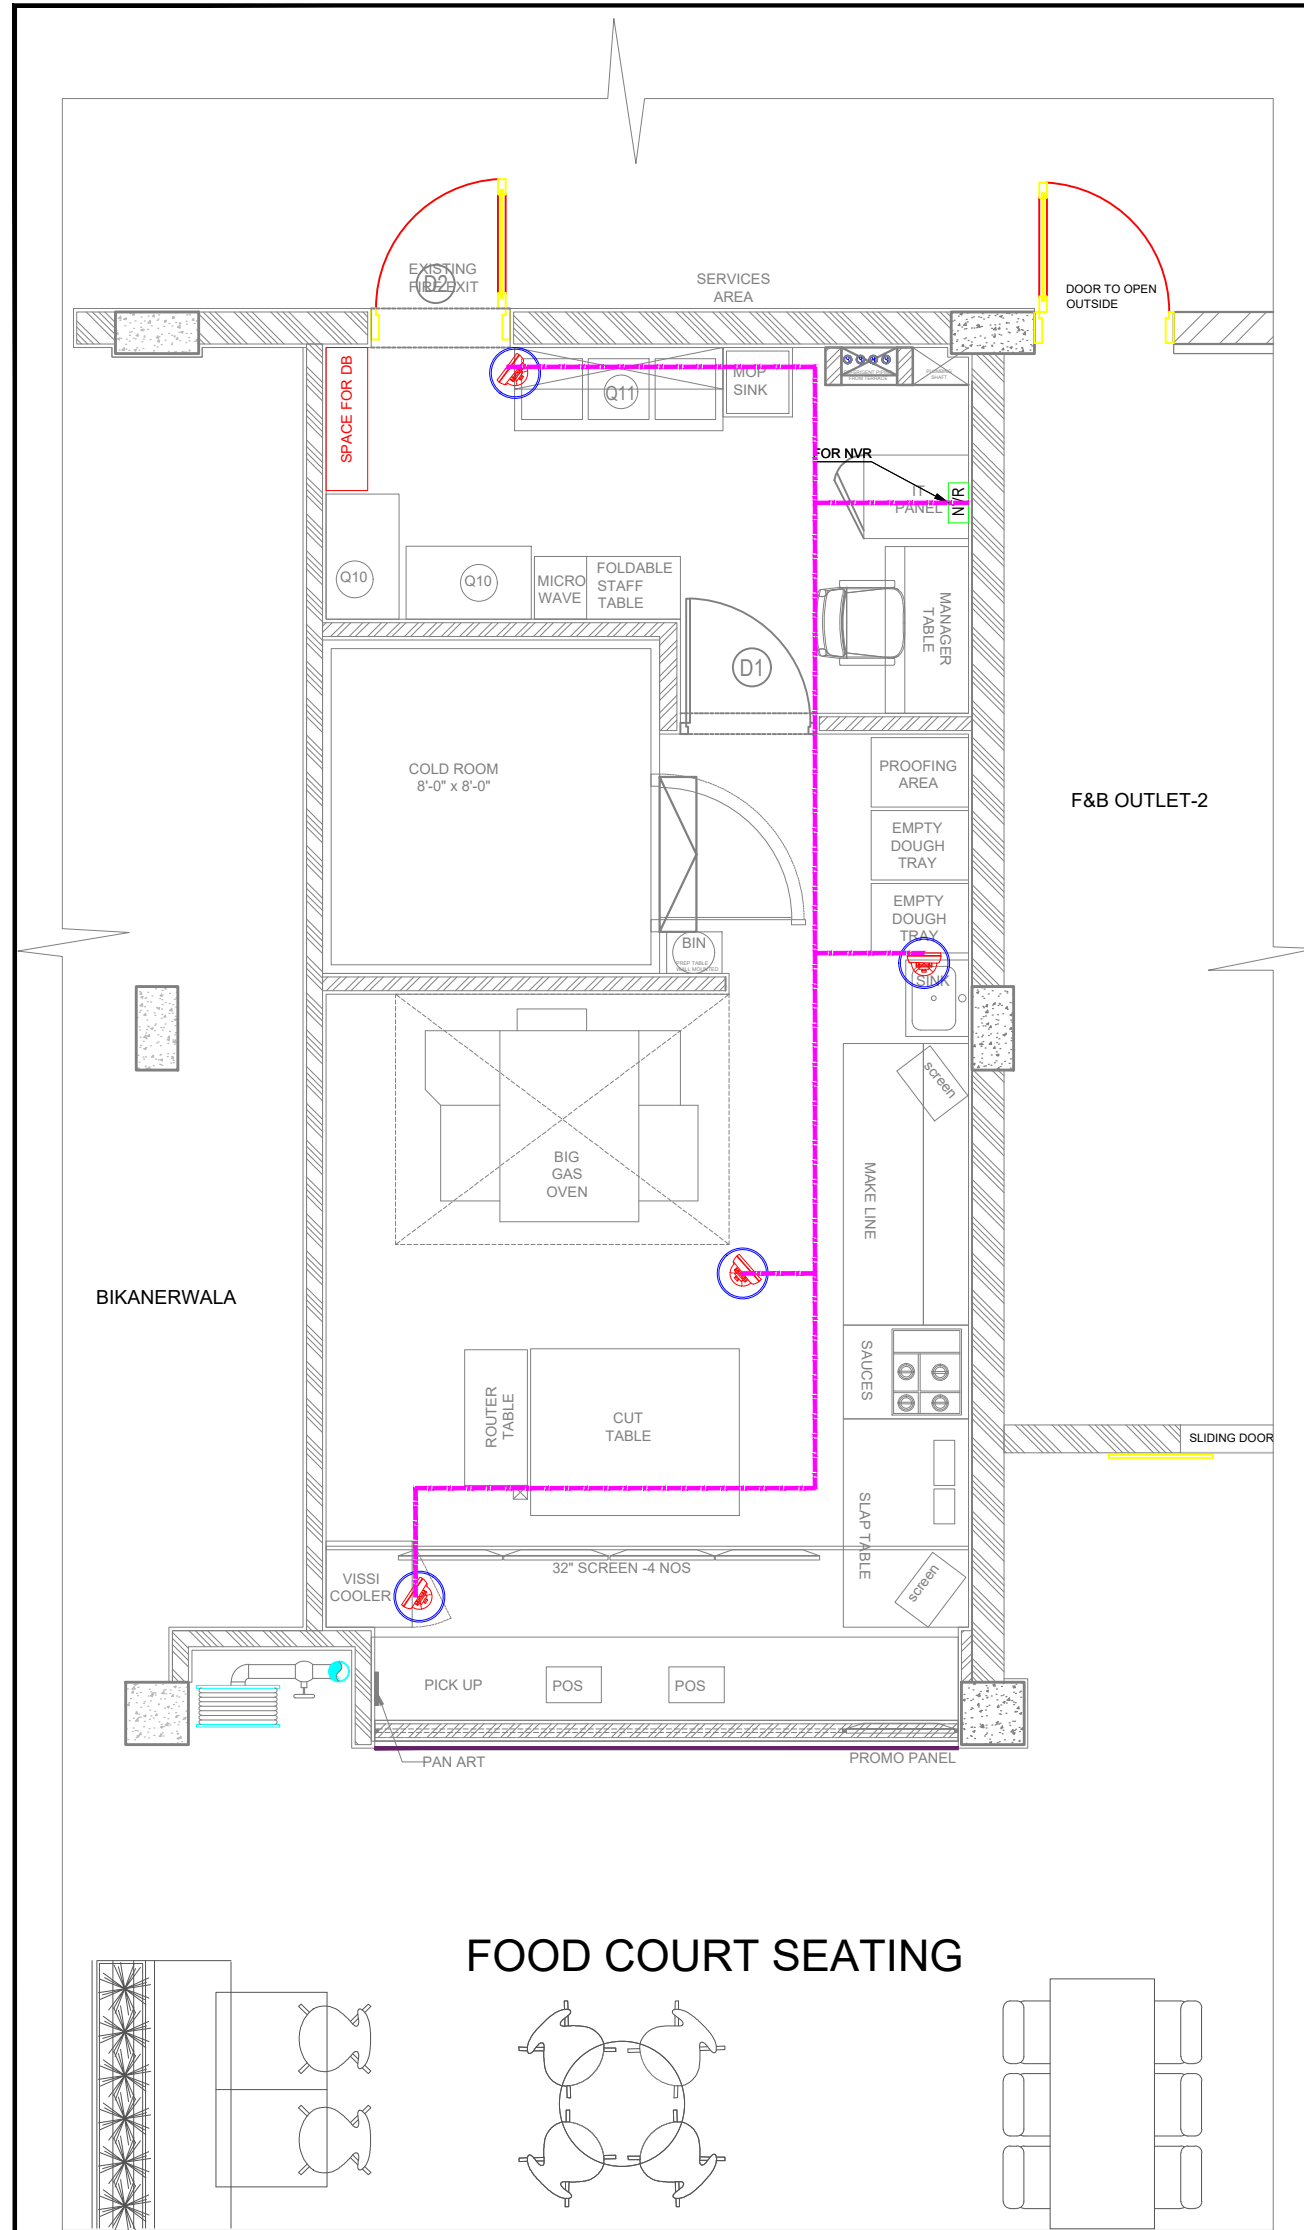

LEGEND

SYM	DESCRIPTION
	CAMERA
	NETWORK VIDEO RECORDING
	CAT 6 WIRE

CARPET AREA - 500 SQ.FT.	
KITCHEN AREA	- 378 SQFT.
BOH AREA	- 122 SQFT.
SLAB BOTTOM - 3680MM	
BEAM BOTTOM - 3238MM	

NOTES

1. ALL DIMENSIONS ARE IN MM.
2. ALL LEVELS INDICATED ARE IN MM.
3. DIMENSIONS / LEVELS INDICATED ARE STRUCTURAL UNLESS OTHERWISE SPECIFIED.
4. THIS DRAWING, UNLESS OTHERWISE MENTIONED, TO BE PLOTTED TO STANDARD A1 SIZE.
5. ONLY WRITTEN DIMENSIONS TO BE FOLLOWED. DO NOT SCALE THE DRAWING.
6. DIMENSIONS / LEVELS SHOWN TO BE VERIFIED AT SITE BEFORE COMMENCEMENT OF WORK ANY DISCREPANCIES IF NOTED, SHOULD BE BROUGHT TO THE NOTICE OF ARCHITECT PRIOR TO COMMENCEMENT OF WORK.
7. RELEVANT SERVICES DRAWINGS ARE TO BE READ SIMULTANEOUSLY AND PROVISION OF CUTOUTS/SLEEVES TO BE PROVIDED AS REQUIRED.
8. ALL MATERIALS / FINISHES TO BE AS SPECIFIED AND APPROVED BY THE CONSULTANTS.

CLIENT:

Domino's

PURPOSE OF RELEASE
RINK MALL-DARJEELING


MEP CONSULTANTS:
CRESCENT ENGINEERS

PROJECT
KHALGHAT - MP

STUDIOSQUARE
ARCHITECTS & INTERIOR DESIGNERS
23/24, KALPITA ENCLAVE, 8/ N. ROAD, ANDHERI-EST,
MUMBAI 400 087 TEL: +91 22 394 2193

DWG NO.	142-24 / 170	R0	00
DRAWING:	CCTV PLAN		
DRAWN BY:	CHKD BY:	SCALE:	DATE:
SAJJAD	AAMIR	1:50	05/03/2024

THIS DRAWING IS THE SOLE PROPERTY OF STUDIO SQUARE IT'S USE FOR ANY PURPOSE OTHER THAN THAT MENTIONED IS TO BE DONE ONLY AFTER PRIOR APPROVAL.

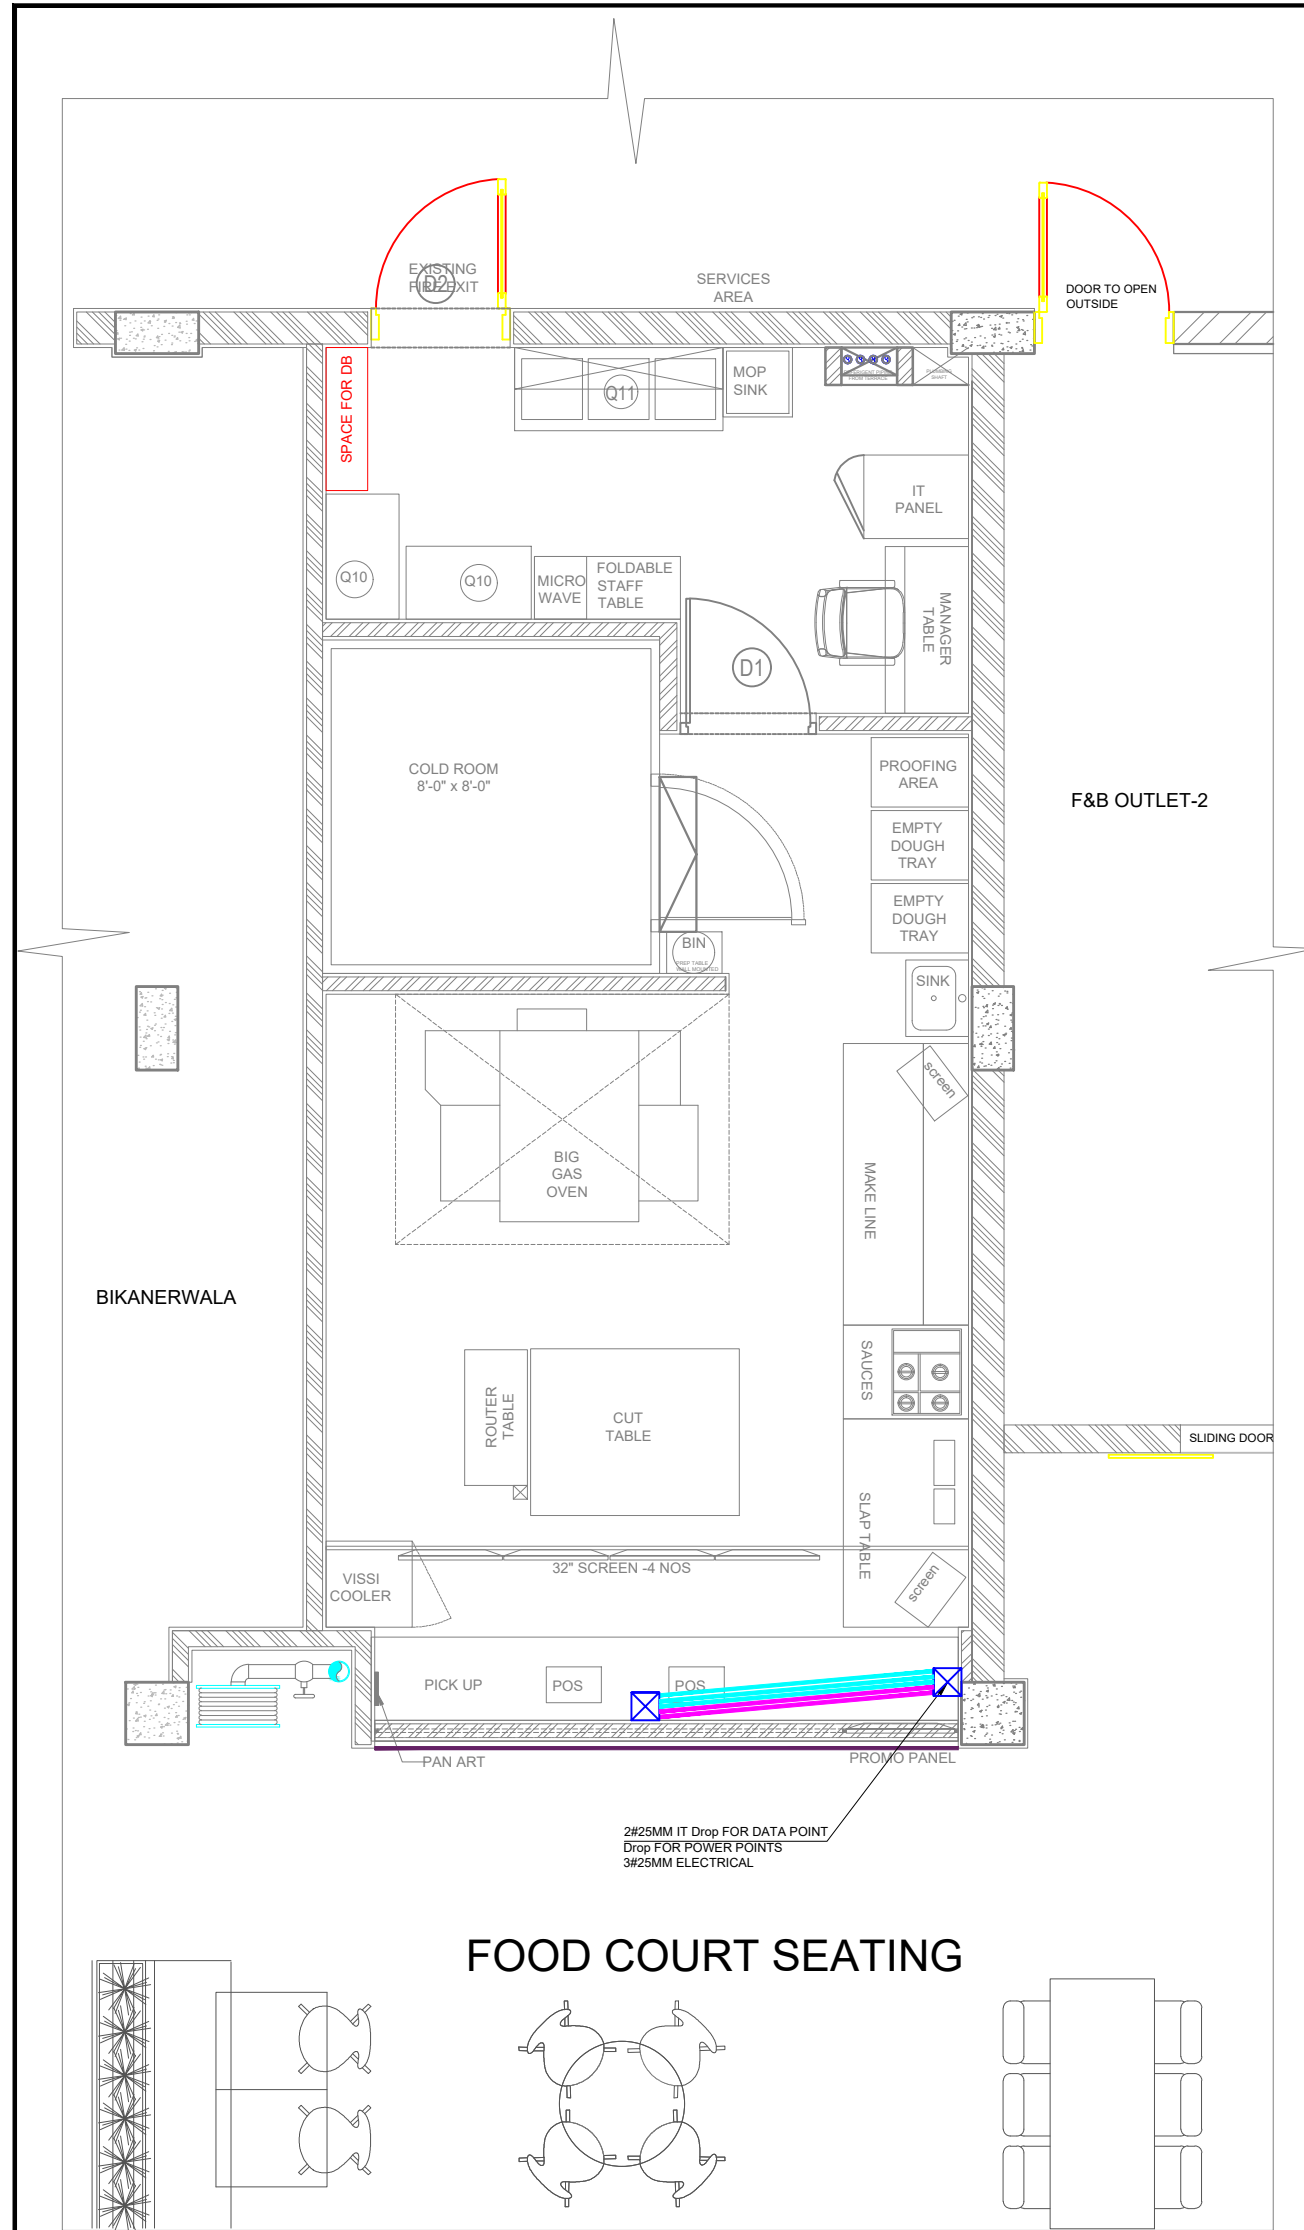


LEGEND:-CONDUIT	
SYMBOL	DESCRIPTION
⊠ (pink)	100 mm. JUNCTION BOX
⊠ (orange)	150 mm. JUNCTION BOX
⊠ (blue)	200 mm. JUNCTION BOX
— (pink)	25 MM. PVC CONDUIT (POWER)
— (cyan)	25 MM. PVC CONDUIT (DATA)

CARPET AREA - 500 SQ.FT.	
KITCHEN AREA	- 378 SQFT.
BOH AREA	- 122 SQFT.
SLAB BOTTOM - 3680MM	
BEAM BOTTOM - 3238MM	

NOTES

- 1.ALL DIMENSIONS ARE IN MM.
- 2.ALL LEVELS INDICATED ARE IN MM.
- 3.DIMENSIONS / LEVELS INDICATED ARE STRUCTURAL UNLESS OTHER SPECIFIED.
- 4.THIS DRAWING, UNLESS OTHERWISE MENTIONED, TO BE PLOTTED TO STANDARD A1 SIZE.
- 5.ONLY WRITTEN DIMENSIONS TO BE FOLLOWED.DO NOT SCALE THE DRAWING
- 6.DIMENSIONS / LEVELS SHOWN TO BE VERIFIED AT SITE BEFORE COMMENCEMENT OF WORK ANY DISCREPANCIES IF NOTED, SHOULD BE BROUGHT TO THE NOTICE OF ARCHITECT.PRIOR TO COMMENCEMENT OF WORK.
- 7.RELEVANT SERVICES DRAWINGS ARE TO BE READ SIMULTANEOUSLY AND PROVISION OF CUTOUTS/SLEEVES TO BE PROVIDED AS REQUIRED.
- 8.ALL MATERIALS / FINISHES TO BE AS SPECIFIED AND APPROVED BY THE CONSULTANTS.


CLIENT:



PURPOSE OF RELEASE
RINK MALL-DARJEELING


MEP CONSULTANTS:
CRESCENT ENGINEERS

PROJECT
KHALGHAT - MP



DWG NO.	142-24 / 168	R0	00
DRAWING:	CONDUIT PLAN		
DRAWN BY:	CHKD BY:	SCALE:	DATE:
SAJJAD	AAMIR	1:50	05/03/2024

THIS DRAWING IS THE SOLE PROPERTY OF STUDIO SQUARE IT'S USE FOR ANY PURPOSE OTHER THAN THAT MENTIONED IS TO BE DONE ONLY AFTER PRIOR APPROVAL.

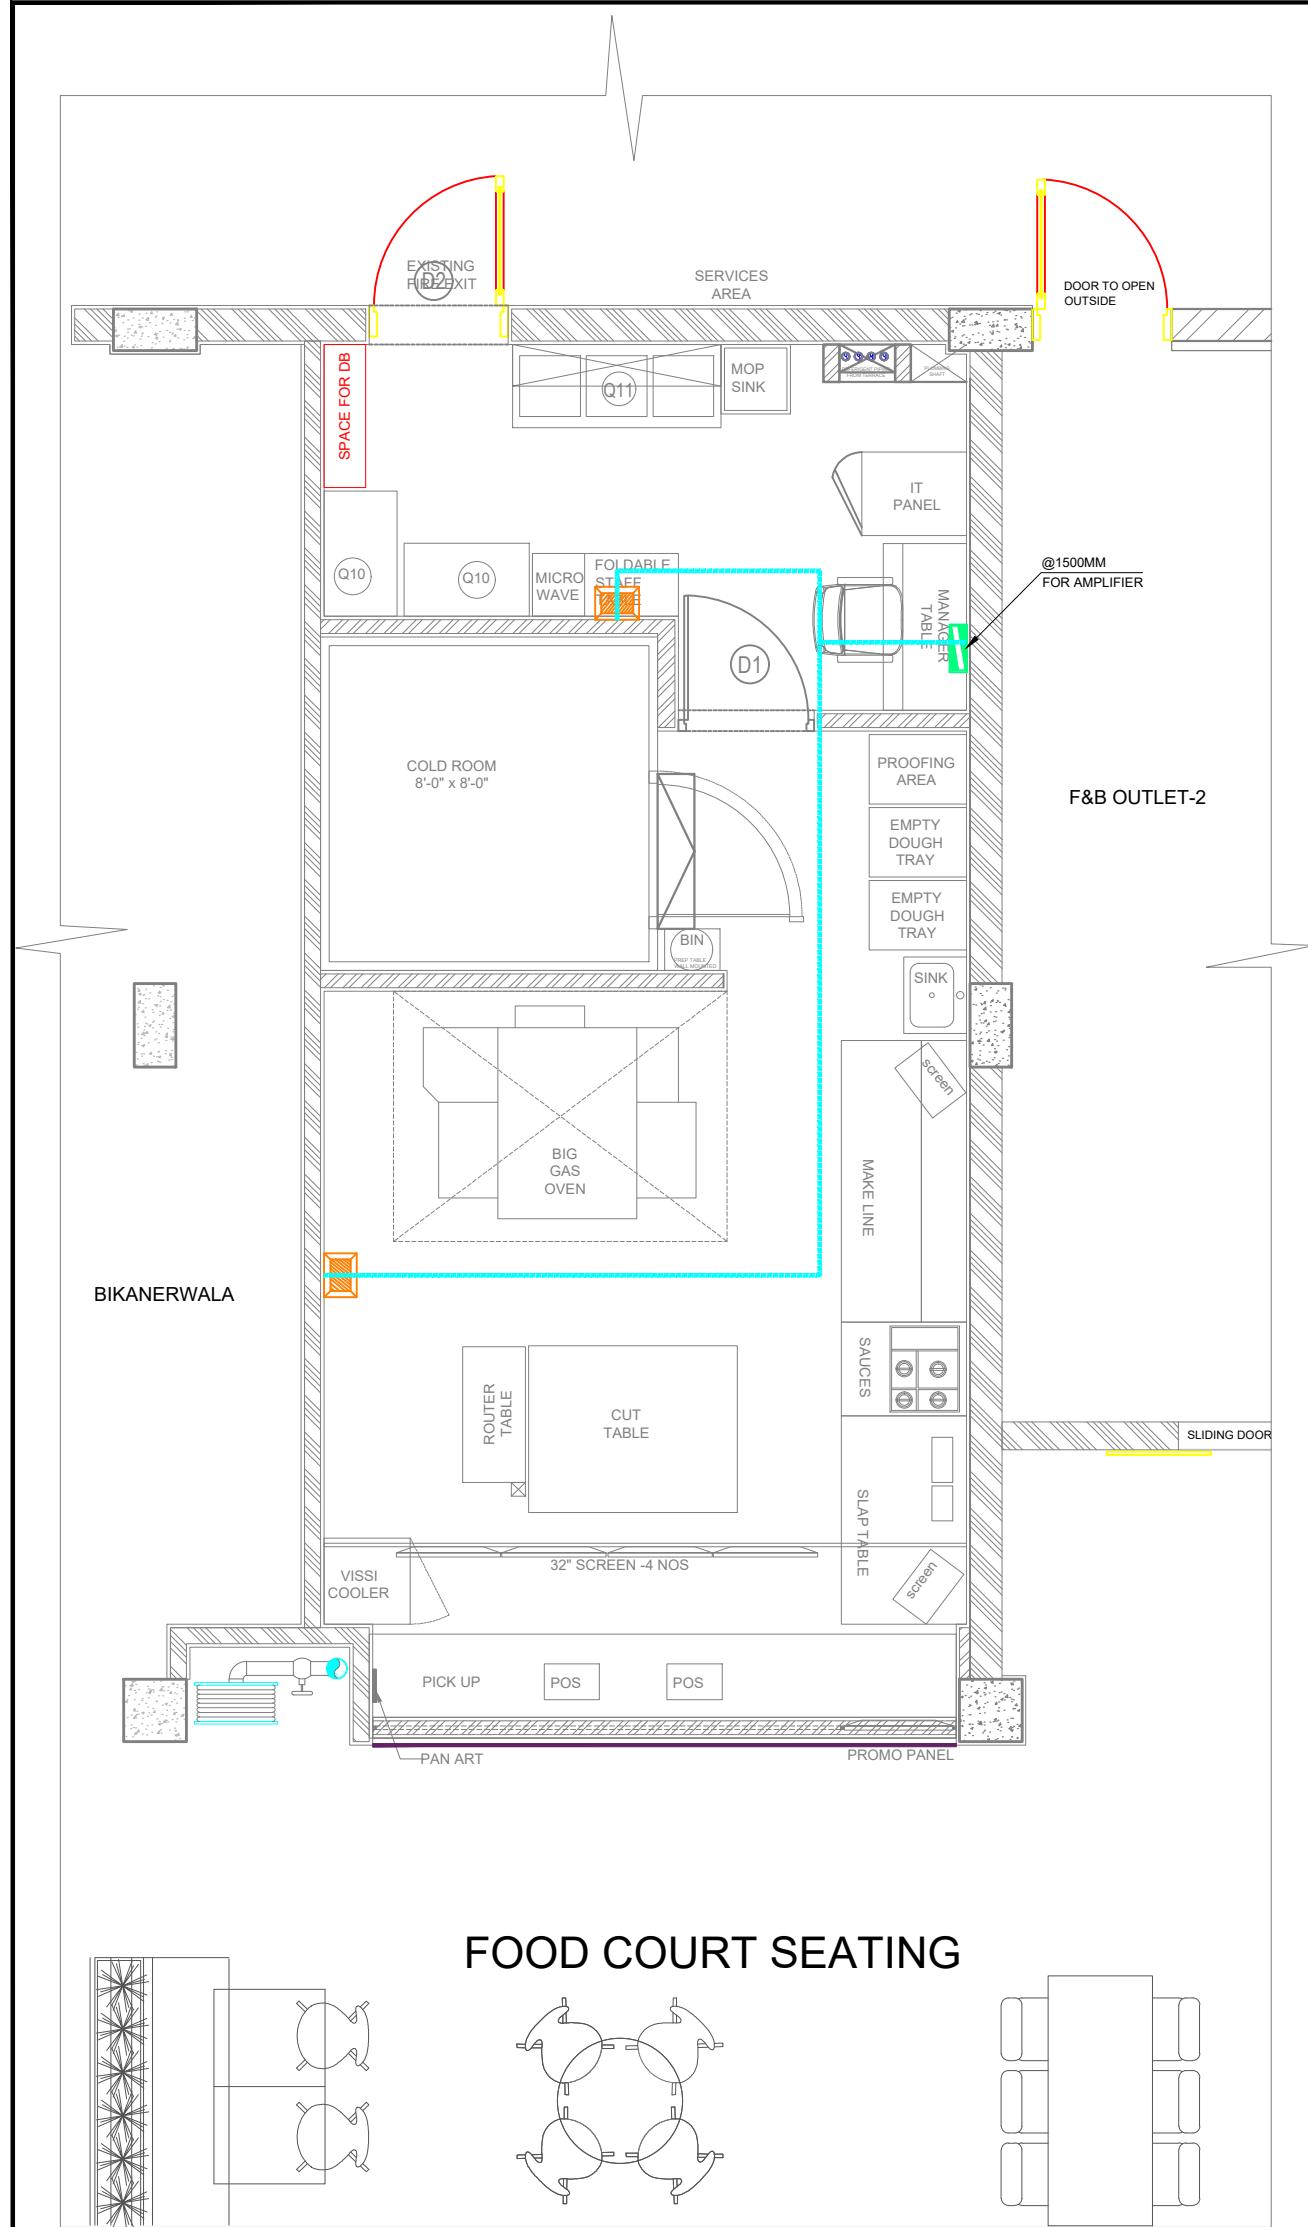


LEGEND:

SYM	DESCRIPTION
	SPEAKER
	AMPLIFIER
	Cable Spec. = 2 Core 1 SQ.MM Cable

BIKANERWALA

FOOD COURT SEATING

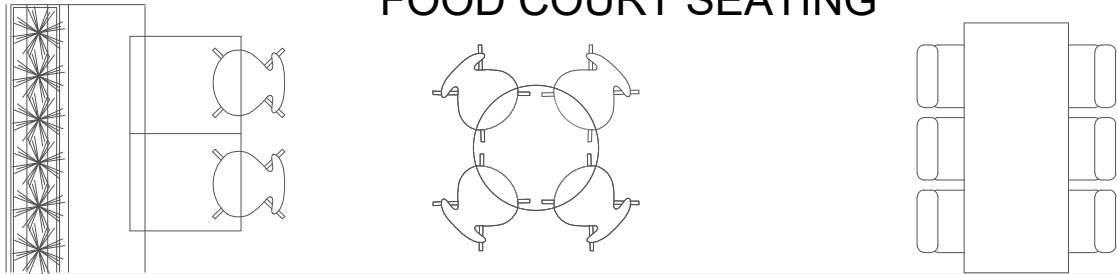

CARPET AREA - 500 SQ.FT.	
KITCHEN AREA	- 378 SQFT.
BOH AREA	- 122 SQFT.
SLAB BOTTOM - 3680MM	
BEAM BOTTOM - 3238MM	

NOTES

1. ALL DIMENSIONS ARE IN MM.
2. ALL LEVELS INDICATED ARE IN MM.
3. DIMENSIONS / LEVELS INDICATED ARE STRUCTURAL UNLESS OTHERWISE SPECIFIED.
4. THIS DRAWING, UNLESS OTHERWISE MENTIONED, TO BE PLOTTED TO STANDARD A1 SIZE.
5. ONLY WRITTEN DIMENSIONS TO BE FOLLOWED. DO NOT SCALE THE DRAWING.
6. DIMENSIONS / LEVELS SHOWN TO BE VERIFIED AT SITE BEFORE COMMENCEMENT OF WORK ANY DISCREPANCIES IF NOTED, SHOULD BE BROUGHT TO THE NOTICE OF ARCHITECT PRIOR TO COMMENCEMENT OF WORK.
7. RELEVANT SERVICES DRAWINGS ARE TO BE READ SIMULTANEOUSLY AND PROVISION OF CUTOUTS/SLEEVES TO BE PROVIDED AS REQUIRED.
8. ALL MATERIALS / FINISHES TO BE AS SPECIFIED AND APPROVED BY THE CONSULTANTS.

CLIENT:




PURPOSE OF RELEASE
RINK MALL-DARJEELING
MEP CONSULTANTS:
CRESCENT ENGINEERS
PROJECT
KHALGHAT - MP



DWG NO.	142-24 / 175	R0	00
DRAWING:	PA PLAN		
DRAWN BY:	CHKD BY:	SCALE:	DATE:
SAJJAD	AAMIR	1:50	05/03/2024

THIS DRAWING IS THE SOLE PROPERTY OF STUDIO SQUARE IT'S USE FOR ANY PURPOSE OTHER THAN THAT MENTIONED IS TO BE DONE ONLY AFTER PRIOR APPROVAL.

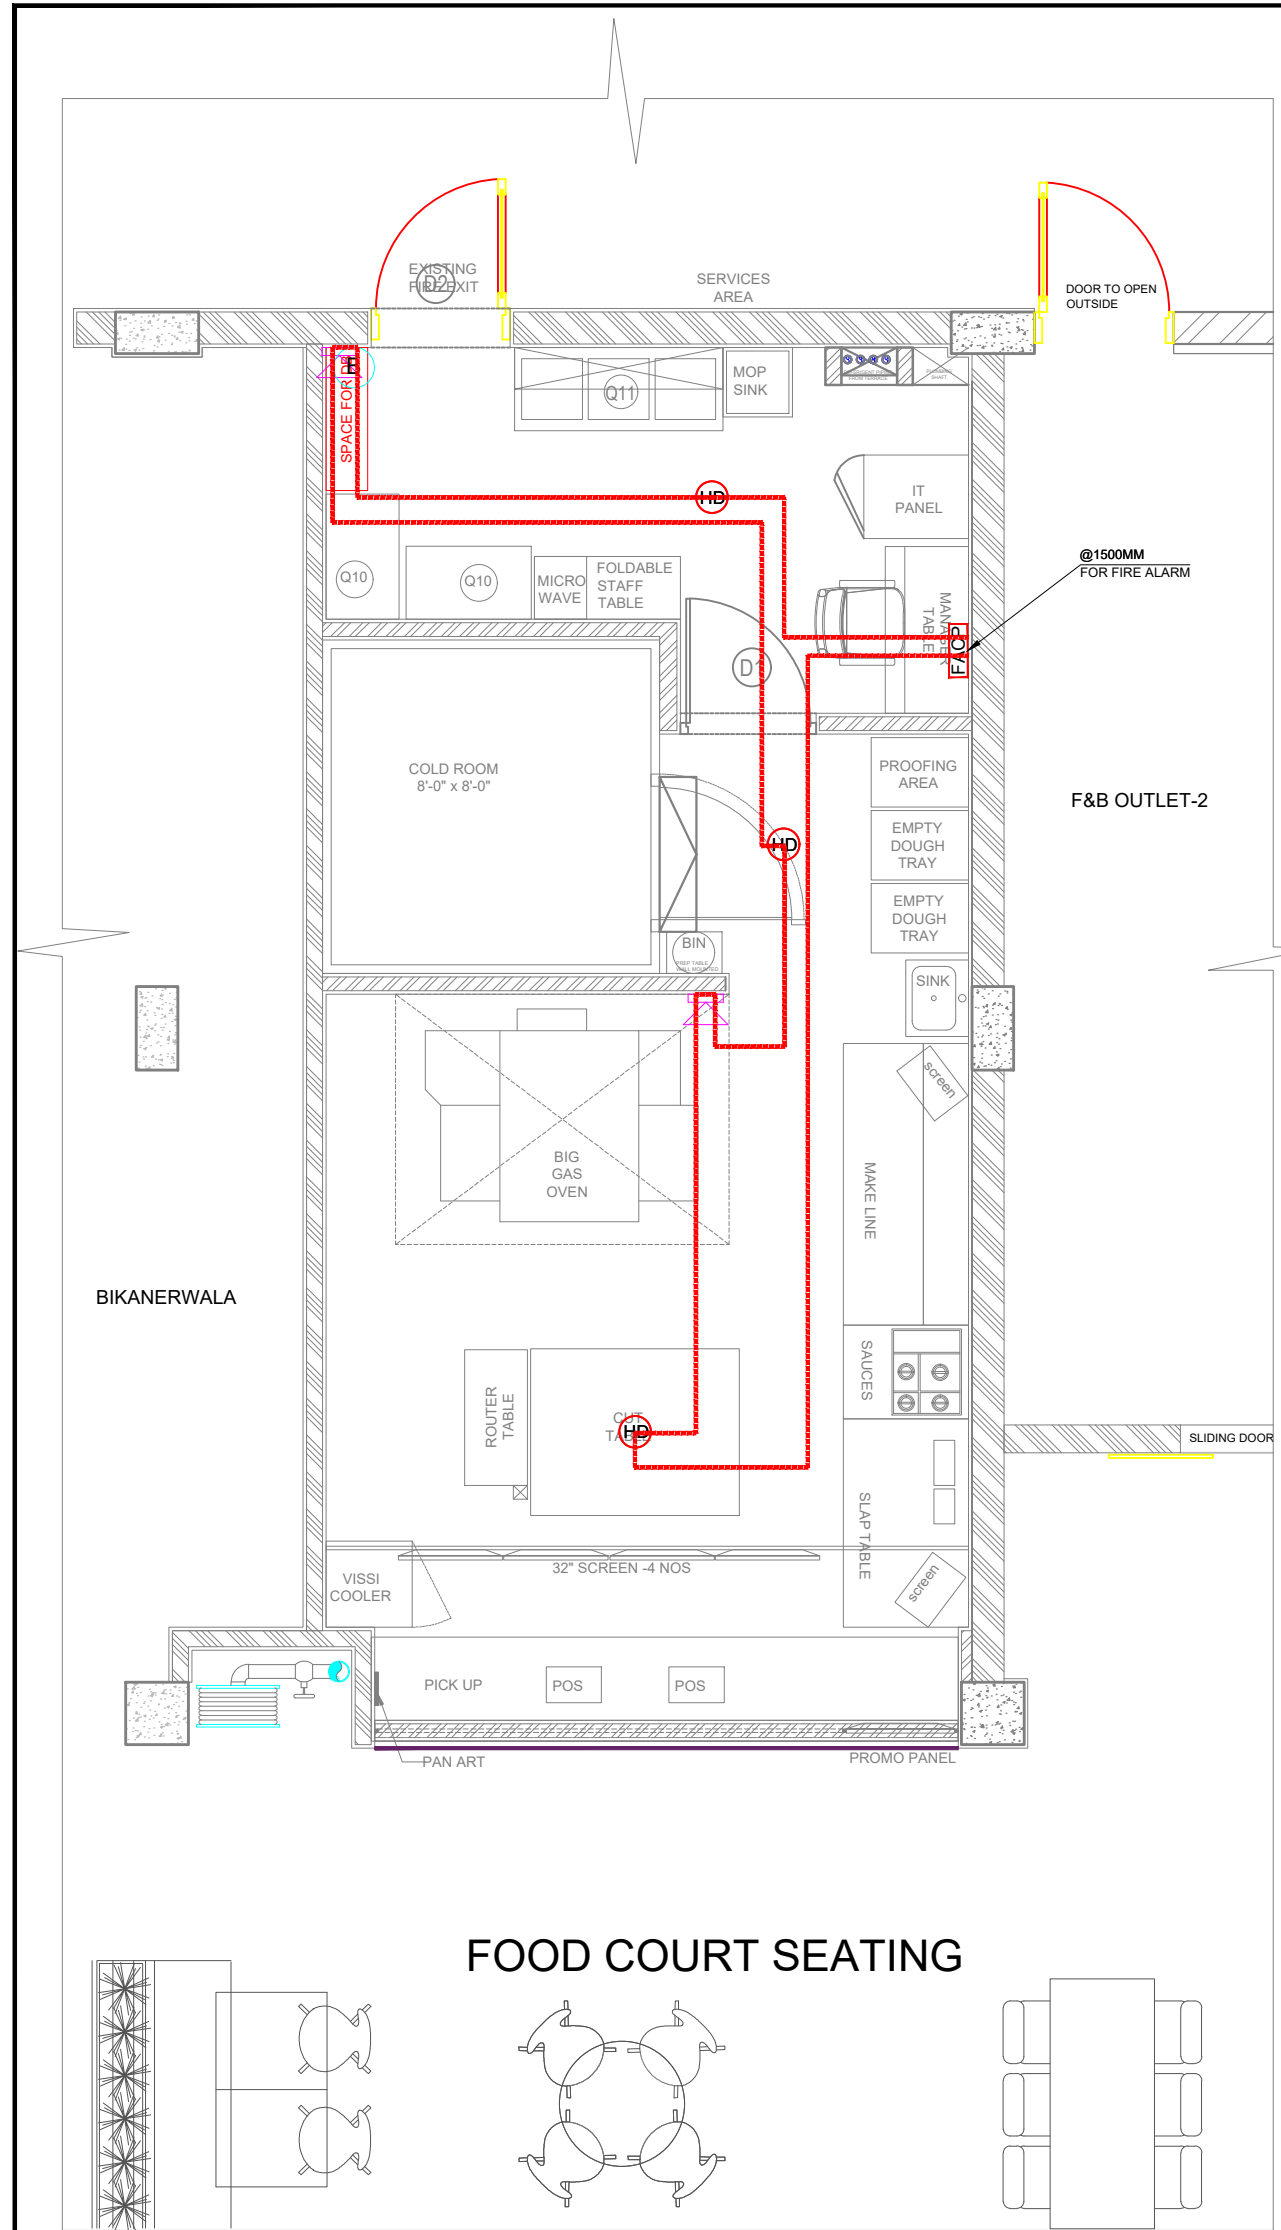


LEGEND:

SYM	DESCRIPTION
SD	SMOKE DETECTOR
AD	ABOVE SMOKE DETECTOR
HD	HEAT DETECTOR
RI	RESPONSE INDICATOR
SH	SIREN/HOOTER
B	MANUAL CALL POINT
FACP	FIRE ALARM CONTROL PANEL
---	2cx1.5mm ² YWY CABLE

CARPET AREA - 500 SQ.FT.	
KITCHEN AREA	- 378 SQFT.
BOH AREA	- 122 SQFT.
SLAB BOTTOM - 3680MM	
BEAM BOTTOM - 3238MM	

FOOD COURT SEATING

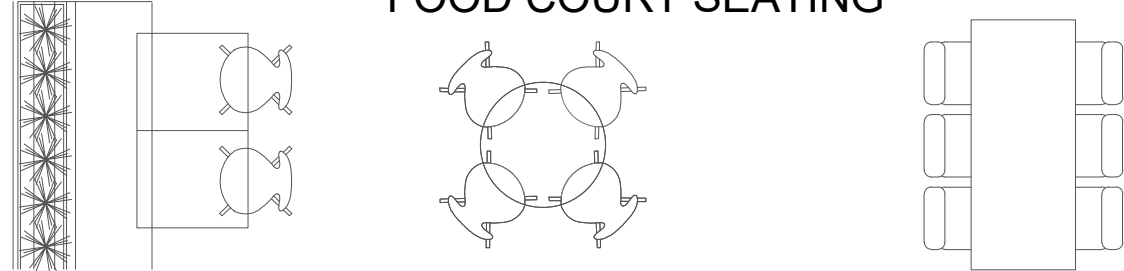

NOTES

1. ALL DIMENSIONS ARE IN MM.
2. ALL LEVELS INDICATED ARE IN MM.
3. DIMENSIONS / LEVELS INDICATED ARE STRUCTURAL UNLESS OTHER SPECIFIED.
4. THIS DRAWING, UNLESS OTHERWISE MENTIONED, TO BE PLOTTED TO STANDARD A1 SIZE.
5. ONLY WRITTEN DIMENSIONS TO BE FOLLOWED. DO NOT SCALE THE DRAWING
6. DIMENSIONS / LEVELS SHOWN TO BE VERIFIED AT SITE BEFORE COMMENCEMENT OF WORK ANY DISCREPANCIES IF NOTED, SHOULD BE BROUGHT TO THE NOTICE OF ARCHITECT PRIOR TO COMMENCEMENT OF WORK.
7. RELEVANT SERVICES DRAWINGS ARE TO BE READ SIMULTANEOUSLY AND PROVISION OF CUTOUTS/SLEEVES TO BE PROVIDED AS REQUIRED.
8. ALL MATERIALS / FINISHES TO BE AS SPECIFIED AND APPROVED BY THE CONSULTANTS.

CLIENT:

Domino's

PURPOSE OF RELEASE
RINK MALL-DARJEELING


MEP CONSULTANTS:
CRESCENT ENGINEERS

PROJECT
KHALGHAT - MP

STUDIOSQUARE
ARCHITECTS & INTERIOR DESIGNERS
23/08, KALPITA ENCLAVE, 8th ROAD, ANDHERI-EST,
MUMBAI 400 087 TEL: 22 3161 2103

DWG NO.	142-24 / 170	R0	00
DRAWING:	SMOKE PLAN		
DRAWN BY:	CHKD BY:	SCALE:	DATE:
SAJJAD	AAMIR	1:50	05/03/2024

THIS DRAWING IS THE SOLE PROPERTY OF STUDIO SQUARE IT'S USE FOR ANY PURPOSE OTHER THAN THAT MENTIONED IS TO BE DONE ONLY AFTER PRIOR APPROVAL.

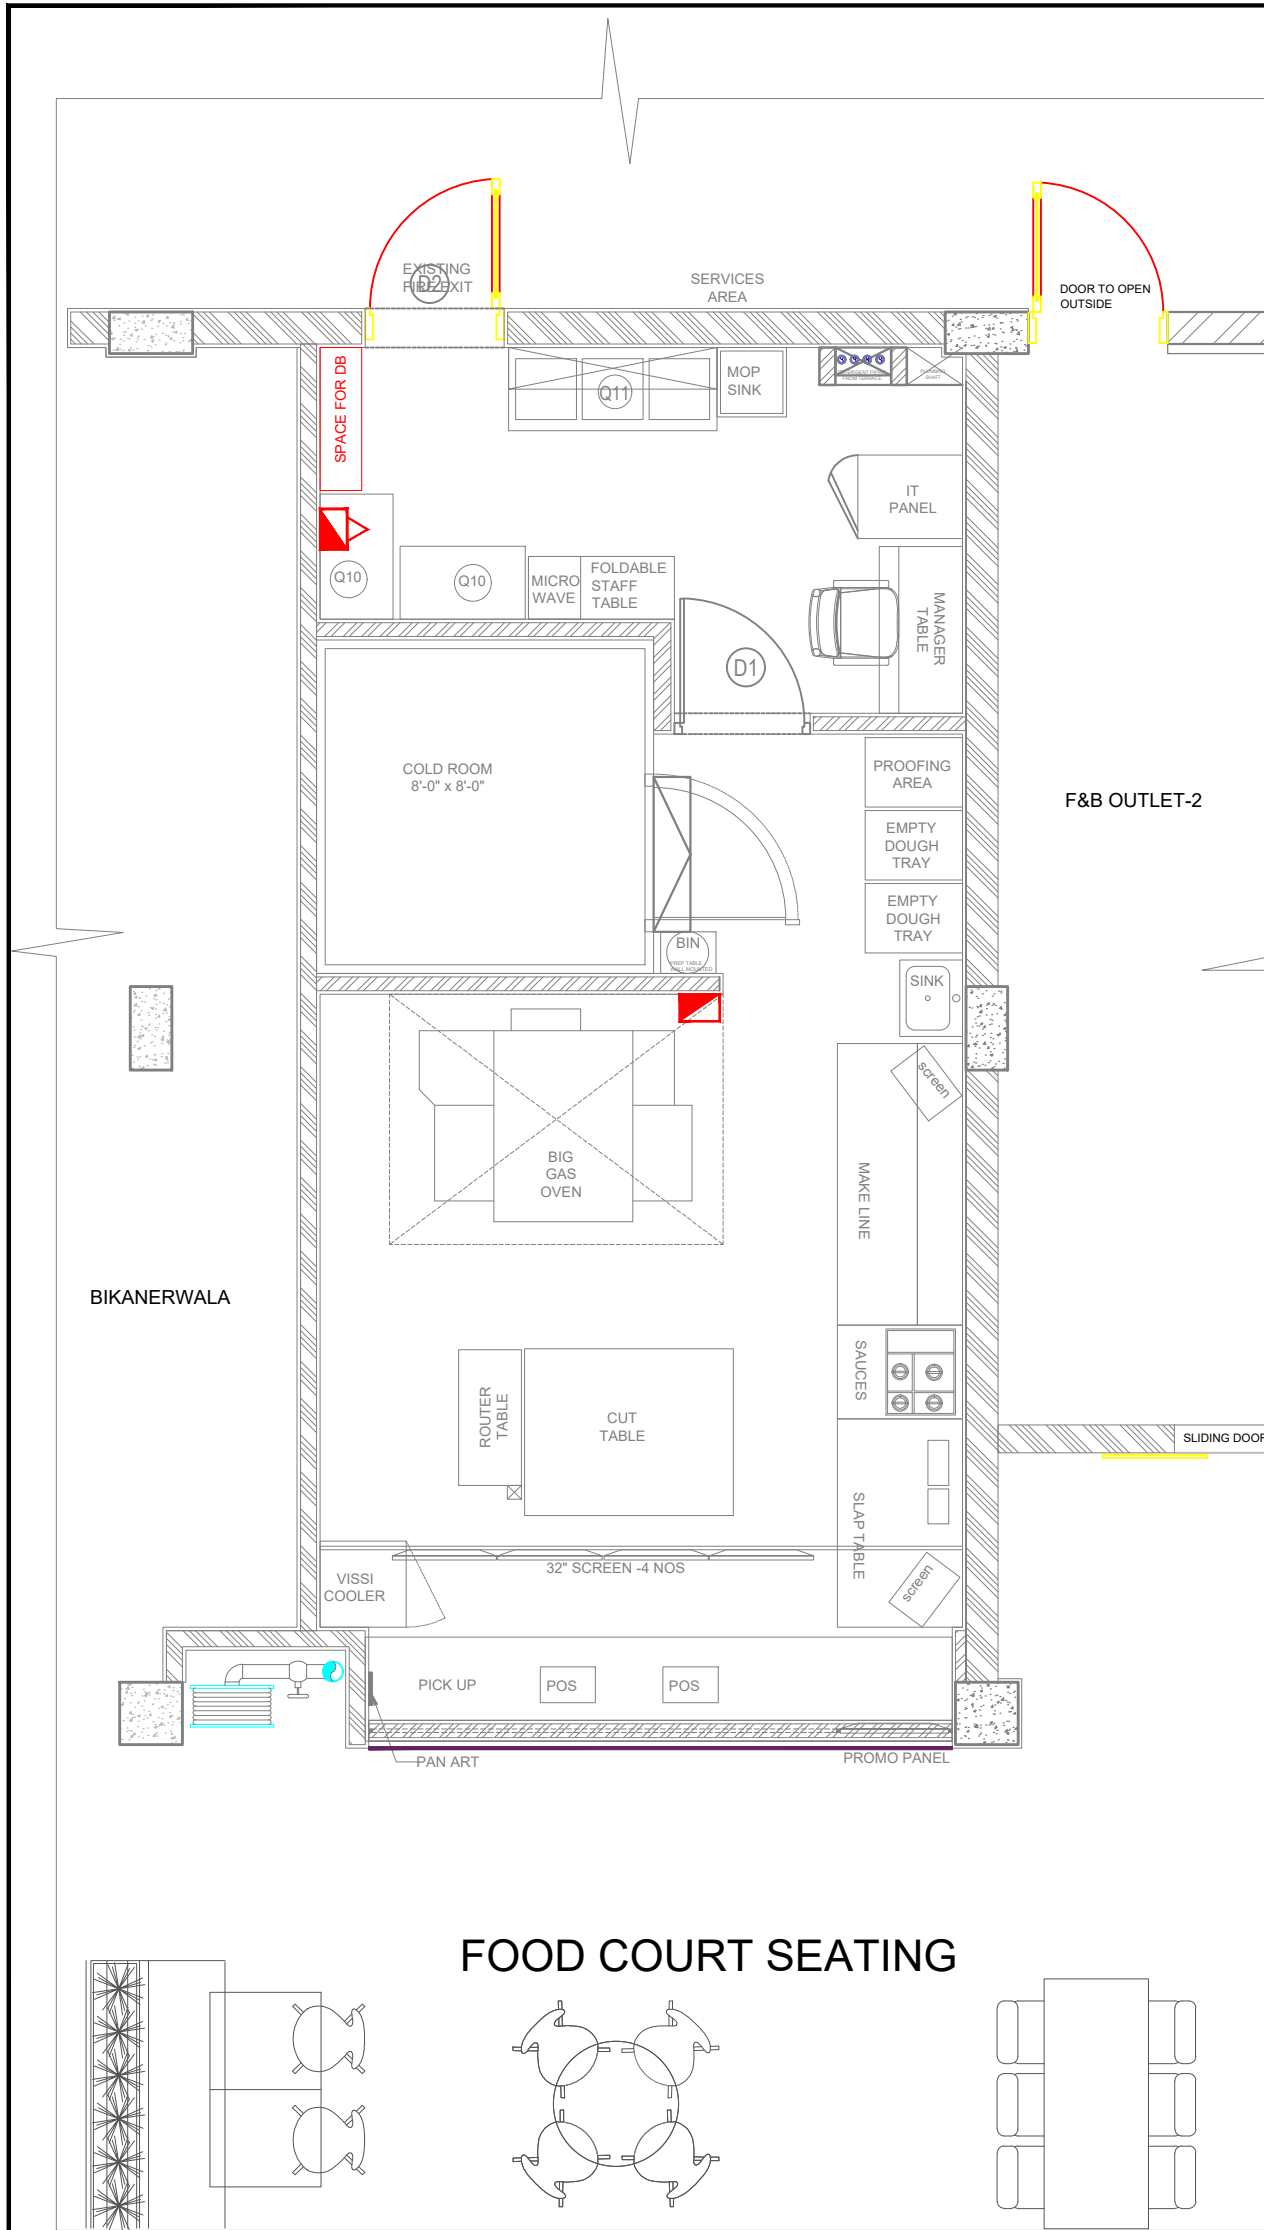

LEGEND:

SYM	DESCRIPTION
	CO2 TYPE EXTINGUISHER 4.5KG
	ABC TYPE FIRE EXTINGUISHER 3KG
	EXIT SIGNANGE ILLUMINATED

CARPET AREA - 500 SQ.FT.	
KITCHEN AREA	- 378 SQFT.
BOH AREA	- 122 SQFT.
SLAB BOTTOM - 3680MM	
BEAM BOTTOM - 3238MM	

NOTES

1. ALL DIMENSIONS ARE IN MM.
2. ALL LEVELS INDICATED ARE IN MM.
3. DIMENSIONS / LEVELS INDICATED ARE STRUCTURAL UNLESS OTHER SPECIFIED.
4. THIS DRAWING, UNLESS OTHERWISE MENTIONED, TO BE PLOTTED TO STANDARD A1 SIZE.
5. ONLY WRITTEN DIMENSIONS TO BE FOLLOWED. DO NOT SCALE THE DRAWING
6. DIMENSIONS / LEVELS SHOWN TO BE VERIFIED AT SITE BEFORE COMMENCEMENT OF WORK ANY DISCREPANCIES IF NOTED, SHOULD BE BROUGHT TO THE NOTICE OF ARCHITECT PRIOR TO COMMENCEMENT OF WORK.
7. RELEVANT SERVICES DRAWINGS ARE TO BE READ SIMULTANEOUSLY AND PROVISION OF CUTOUTS/SLEEVES TO BE PROVIDED AS REQUIRED.
8. ALL MATERIALS / FINISHES TO BE AS SPECIFIED AND APPROVED BY THE CONSULTANTS.

CLIENT:

PURPOSE OF RELEASE
RINK MALL-DARJEELING

MEP CONSULTANTS:
CRESCENT ENGINEERS



PROJECT
KHALGHAT - MP

DWG NO.	142-24 / 185	R0	00
DRAWING:	EVACUATION PLAN		
DRAWN BY:	CHKD BY:	SCALE:	DATE:
SAJJAD	AAMIR	1:50	05/03/2024

THIS DRAWING IS THE SOLE PROPERTY OF STUDIO SQUARE IT'S USE FOR ANY PURPOSE OTHER THAN THAT MENTIONED IS TO BE DONE ONLY AFTER PRIOR APPROVAL.

LEGEND: -FIRE FIGHTING

SYM	DESCRIPTION
	SPRINKLER PIPE
	PENDENT TYPE SPRINKLER
	SIDE WALL TYPE SPRINKLER
	BUTTERFLY VALVE
	FLOW SWITCH
	BALL VALVE
	SIGHT GLASS
	DRAIN PIPE
	5KG ABC TYPE EXRINGUSHER
	5KG CO2 TYPE EXRINGUSHER

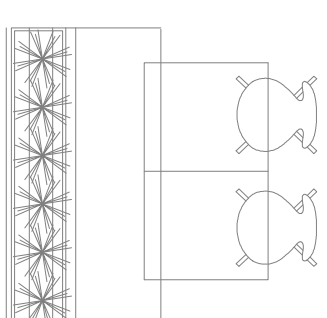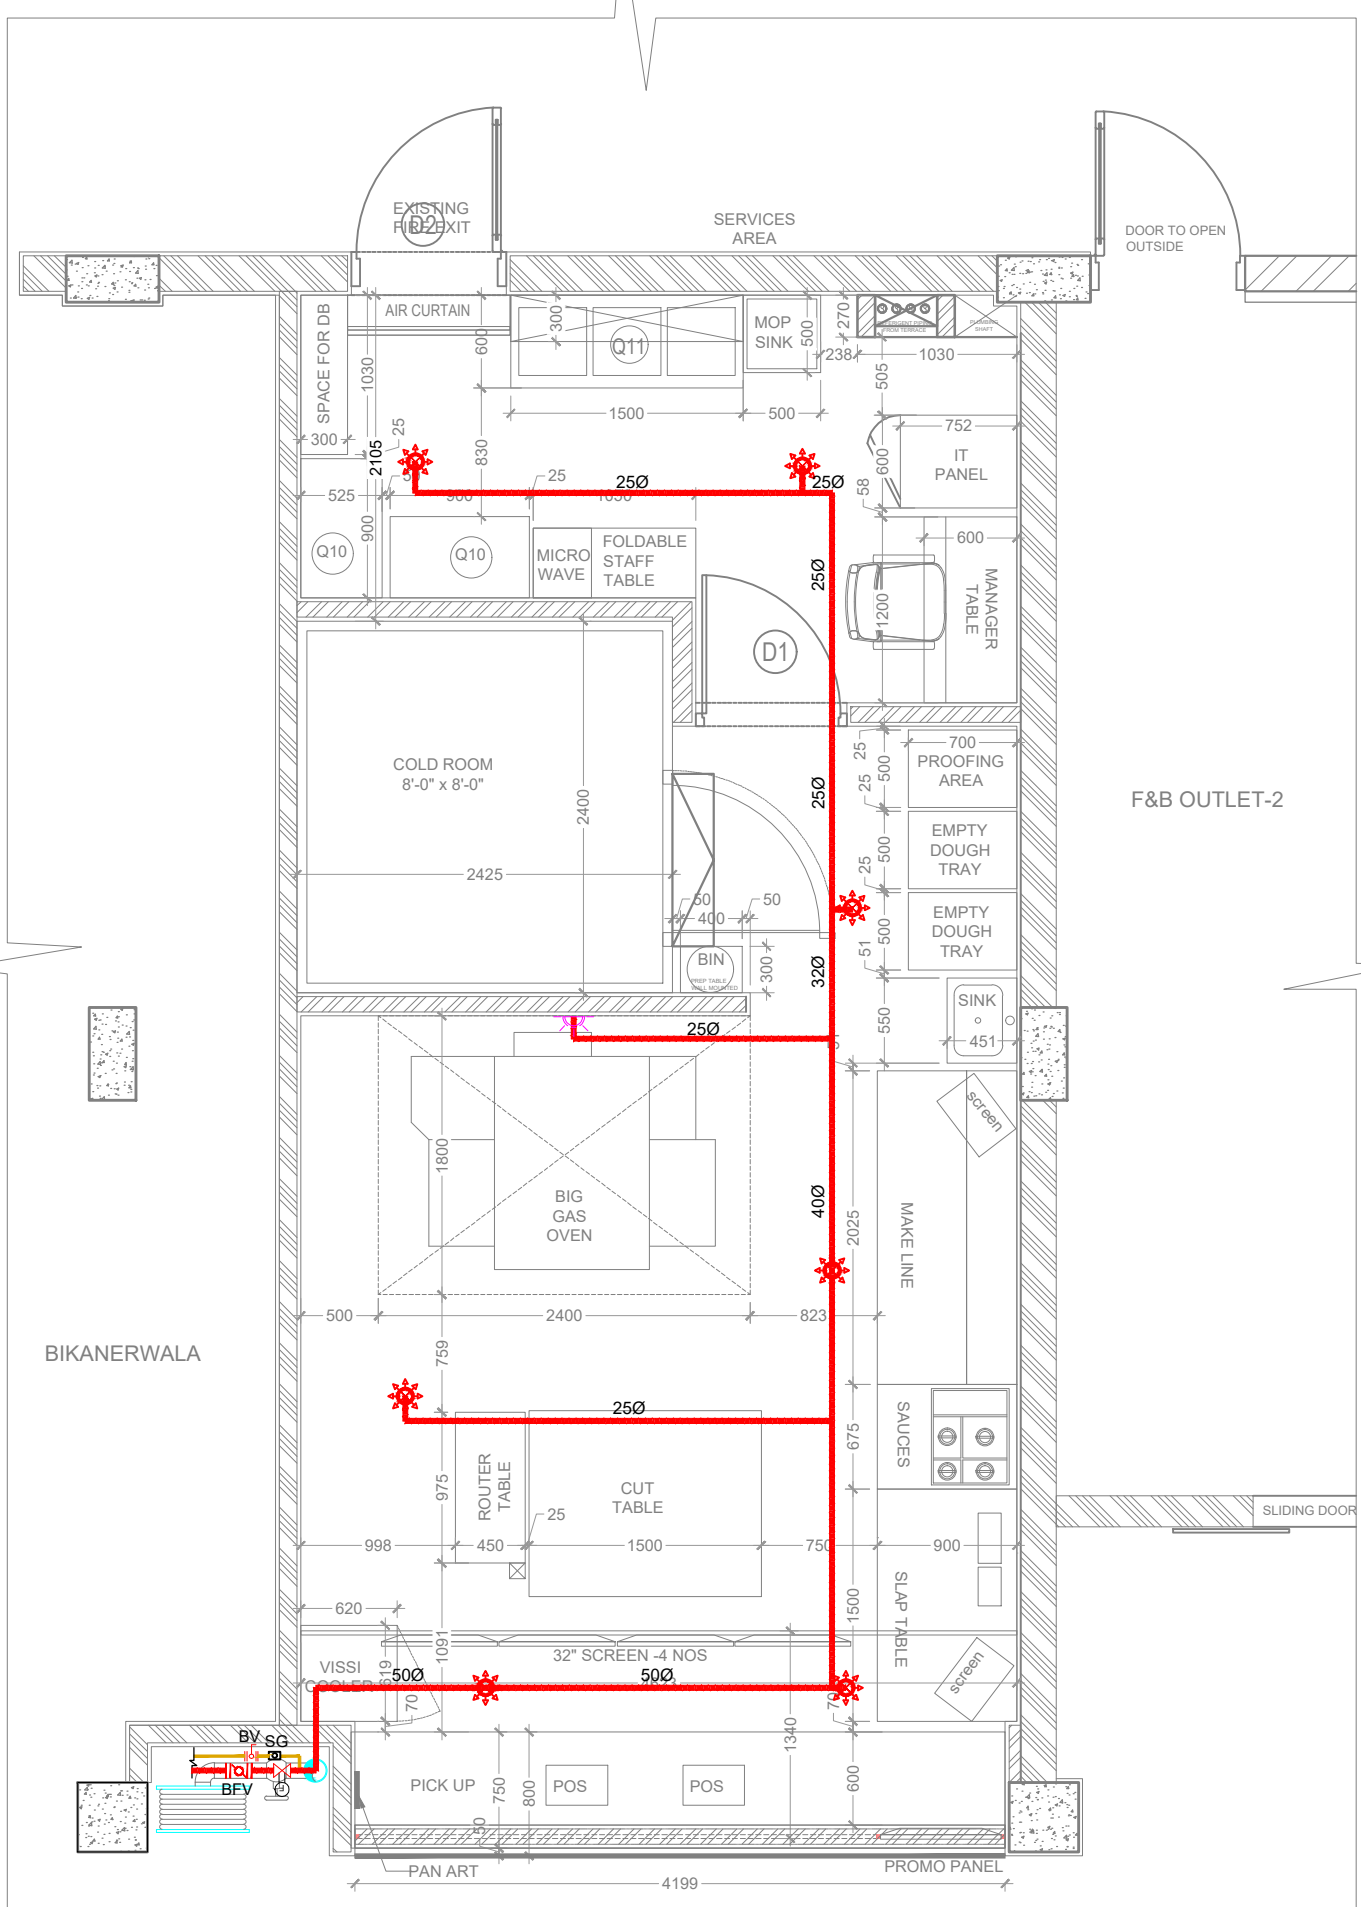

FOOD COURT SEATING

CARPET AREA - 500 SQ.FT.
 KITCHEN AREA - 378 SQFT.
 BOH AREA - 122 SQFT.
 SLAB BOTTOM - 3680MM
 BEAM BOTTOM - 3238MM

NOTES

- 1.ALL DIMENSIONS ARE IN MM.
- 2.ALL LEVELS INDICATED ARE IN MM.
- 3.DIMENSIONS / LEVELS INDICATED ARE STRUCTURAL UNLESS OTHER SPECIFIED.
- 4.THIS DRAWING, UNLESS OTHERWISE MENTIONED, TO BE PLOTTED TO STANDARD A1 SIZE.
- 5.ONLY WRITTEN DIMENSIONS TO BE FOLLOWED.DO NOT SCALE THE DRAWING
- 6.DIMENSIONS / LEVELS SHOWN TO BE VERIFIED AT SITE BEFORE COMMENCEMENT OF WORK ANY DISCREPANCIES IF NOTED, SHOULD BE BROUGHT TO THE NOTICE OF ARCHITECT.PRIOR TO COMMENCEMENT OF WORK.
- 7.RELEVANT SERVICES DRAWINGS ARE TO BE READ SIMULTANEOUSLY AND PROVISION OF CUTOUTS/SLEEVES TO BE PROVIDED AS REQUIRED.
- 8.ALL MATERIALS / FINISHES TO BE AS SPECIFIED AND APPROVED BY THE CONSULTANTS.

CLIENT:

Domino's

PURPOSE OF RELEASE
 RINK MALL-DARJEELING


MEP CONSULTANTS:
 CRESCENT ENGINEERS

PROJECT
 KHALGHAT - MP

STUDIOSQUARE
 ARCHITECTS & INTERIOR SCENARIES
 23/08, KALPITA ENCLAVE, 8th ROAD, ANDHERI (E), MUMBAI 400 089 TEL: +91 22 394 2193


DWG NO.	142-24 / 193	R0	00
DRAWING:	FIRE FIGHTING PLAN		
DRAWN BY:	CHKD BY:	SCALE:	DATE:
VARSHA	GAUTAMI	1:50	23/02/2024

THIS DRAWING IS THE SOLE PROPERTY OF STUDIO SQUARE IT'S USE FOR ANY PURPOSE OTHER THAN THAT MENTIONED IS TO BE DONE ONLY AFTER PRIOR APPROVAL.

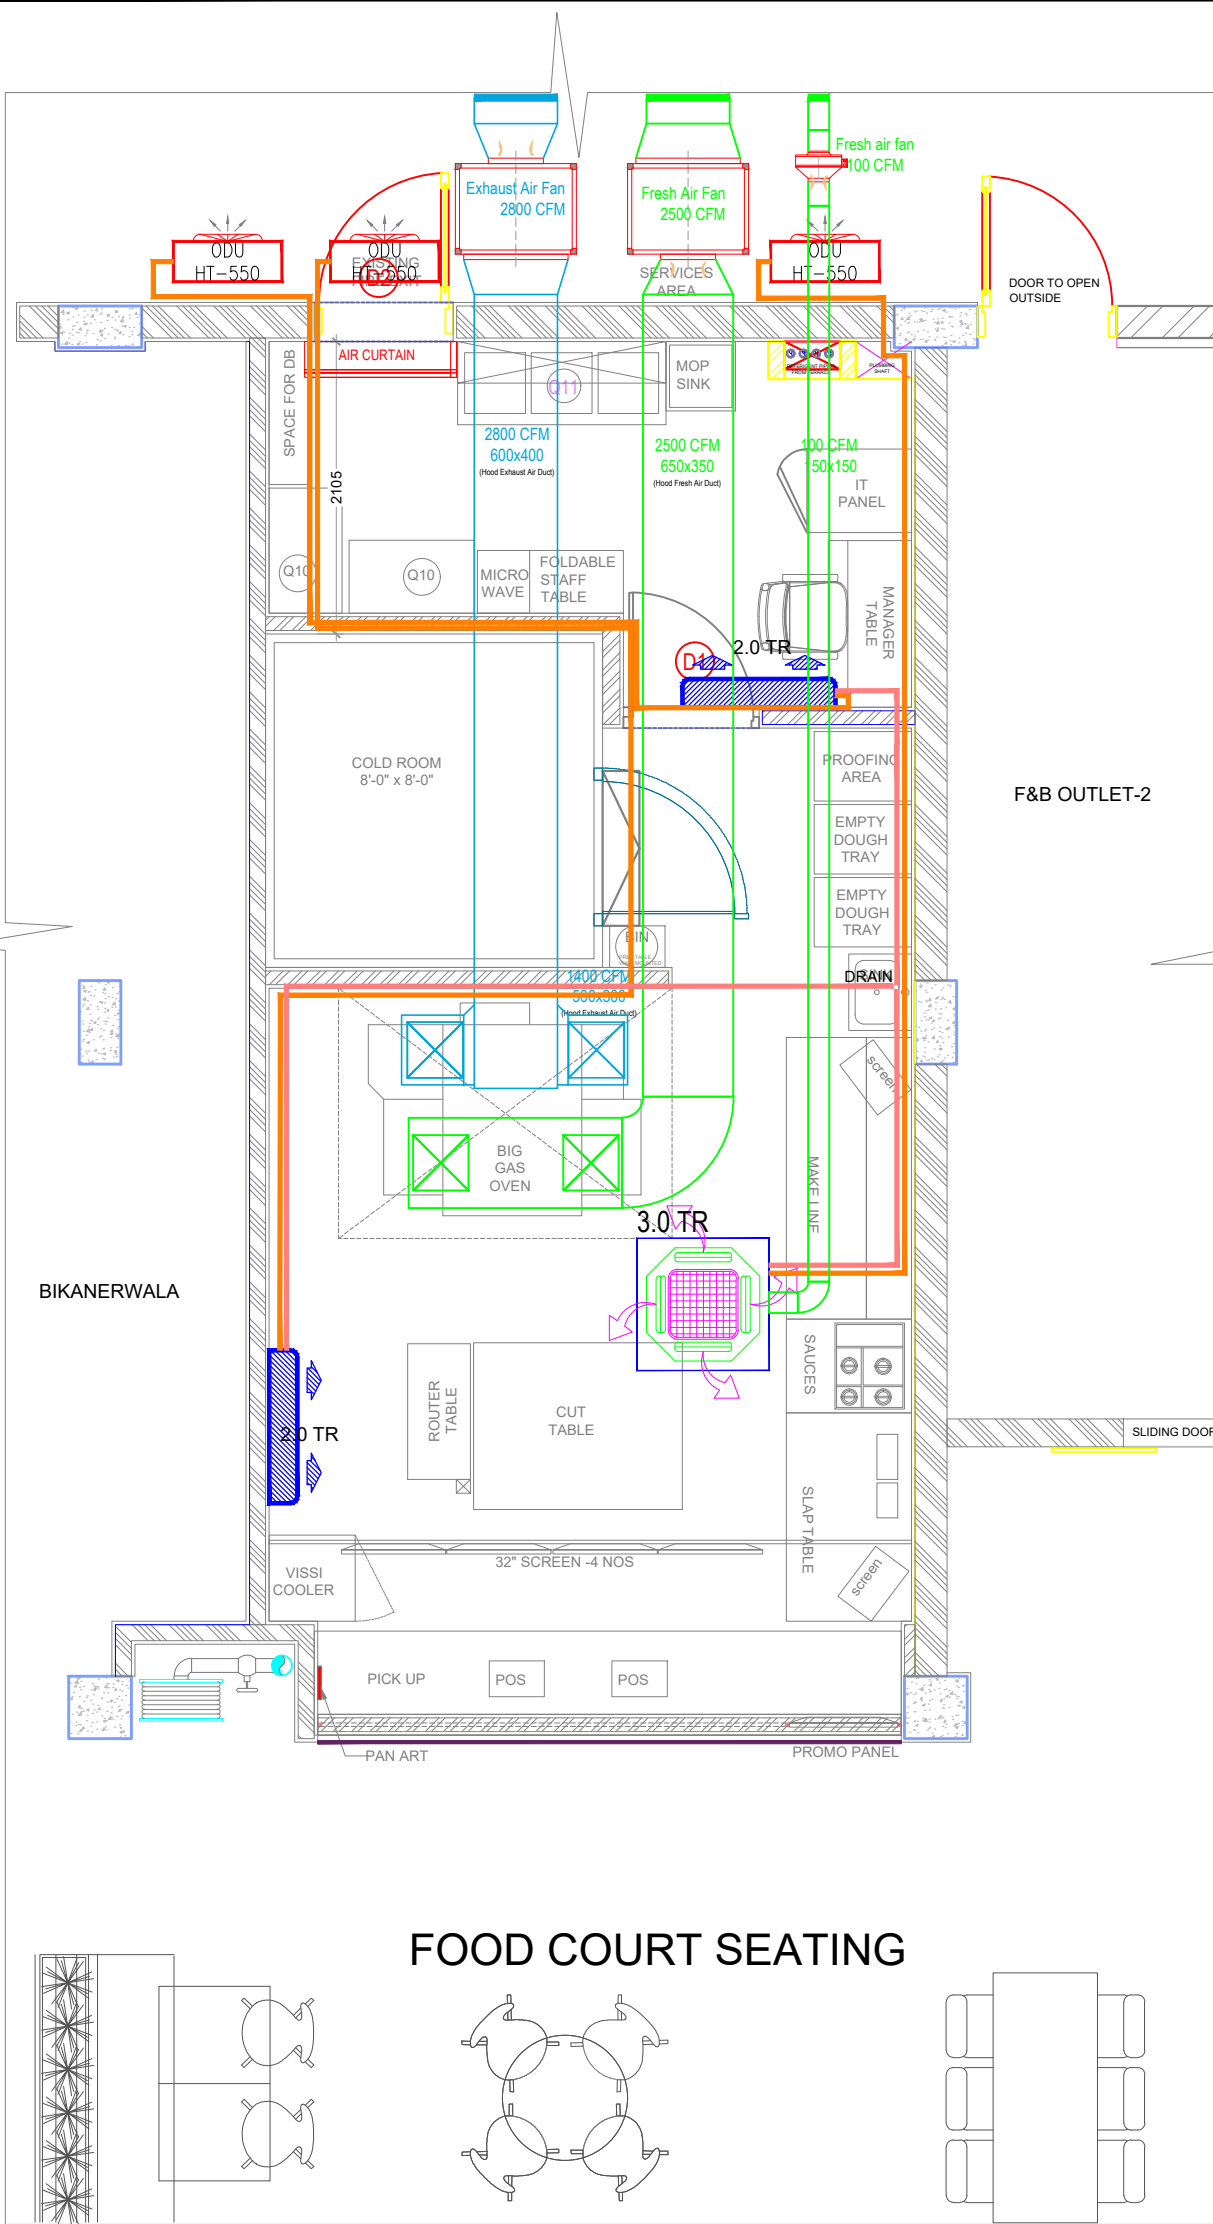

HVAC LEGEND	
SYMBOL	DESCRIPTION
	FRESH AIR DUCT
	EXHAUST AIR DUCT
	HI-WALL UNIT
	DX ODU
	DRAIN PIPE
	COPPER PIPE

FOOD COURT SEATING

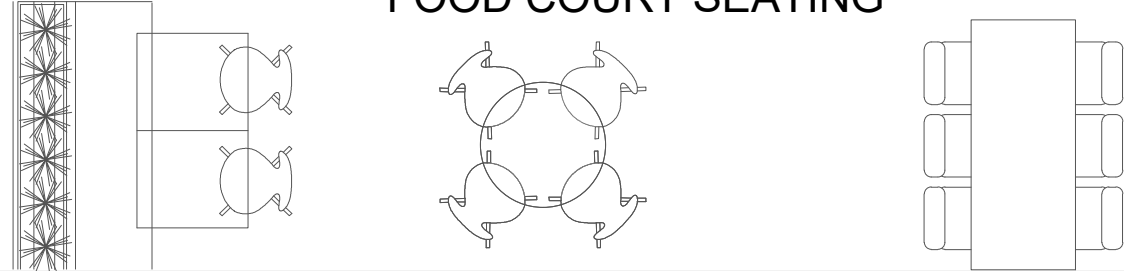

CARPET AREA - 500 SQ.FT.	
KITCHEN AREA	- 378 SQFT.
BOH AREA	- 122 SQFT.
SLAB BOTTOM	- 3680MM
BEAM BOTTOM	- 3238MM

NOTES

1. ALL DIMENSIONS ARE IN MM.
2. ALL LEVELS INDICATED ARE IN MM.
3. DIMENSIONS / LEVELS INDICATED ARE STRUCTURAL UNLESS OTHERWISE SPECIFIED.
4. THIS DRAWING, UNLESS OTHERWISE MENTIONED, TO BE PLOTTED TO STANDARD A1 SIZE.
5. ONLY WRITTEN DIMENSIONS TO BE FOLLOWED. DO NOT SCALE THE DRAWING.
6. DIMENSIONS / LEVELS SHOWN TO BE VERIFIED AT SITE BEFORE COMMENCEMENT OF WORK ANY DISCREPANCIES IF NOTED, SHOULD BE BROUGHT TO THE NOTICE OF ARCHITECT PRIOR TO COMMENCEMENT OF WORK.
7. RELEVANT SERVICES DRAWINGS ARE TO BE READ SIMULTANEOUSLY AND PROVISION OF CUTOUTS/SLEEVES TO BE PROVIDED AS REQUIRED.
8. ALL MATERIALS / FINISHES TO BE AS SPECIFIED AND APPROVED BY THE CONSULTANTS.

CLIENT:

Domino's

PURPOSE OF RELEASE
RINK MALL-DARJEELING


MEP CONSULTANTS:
CRESCENT ENGINEERS

PROJECT
KHALGHAT - MP

STUDIOSQUARE
ARCHITECTS & INTERIOR DESIGNERS
23/09, KALPITA ENCLAVE, 5th FLOOR, ANDHERI-EST,
MUMBAI 400 087 TEL: +91 22 394 2193

DWG NO.	142-24 / 100	R0	00
DRAWING:	HVAC PLAN		
DRAWN BY:	CHKD BY:	SCALE:	DATE:
SAKIB	AAMIR	1:50	05/03/2024

THIS DRAWING IS THE SOLE PROPERTY OF STUDIO SQUARE IT'S USE FOR ANY PURPOSE OTHER THAN THAT MENTIONED IS TO BE DONE ONLY AFTER PRIOR APPROVAL.

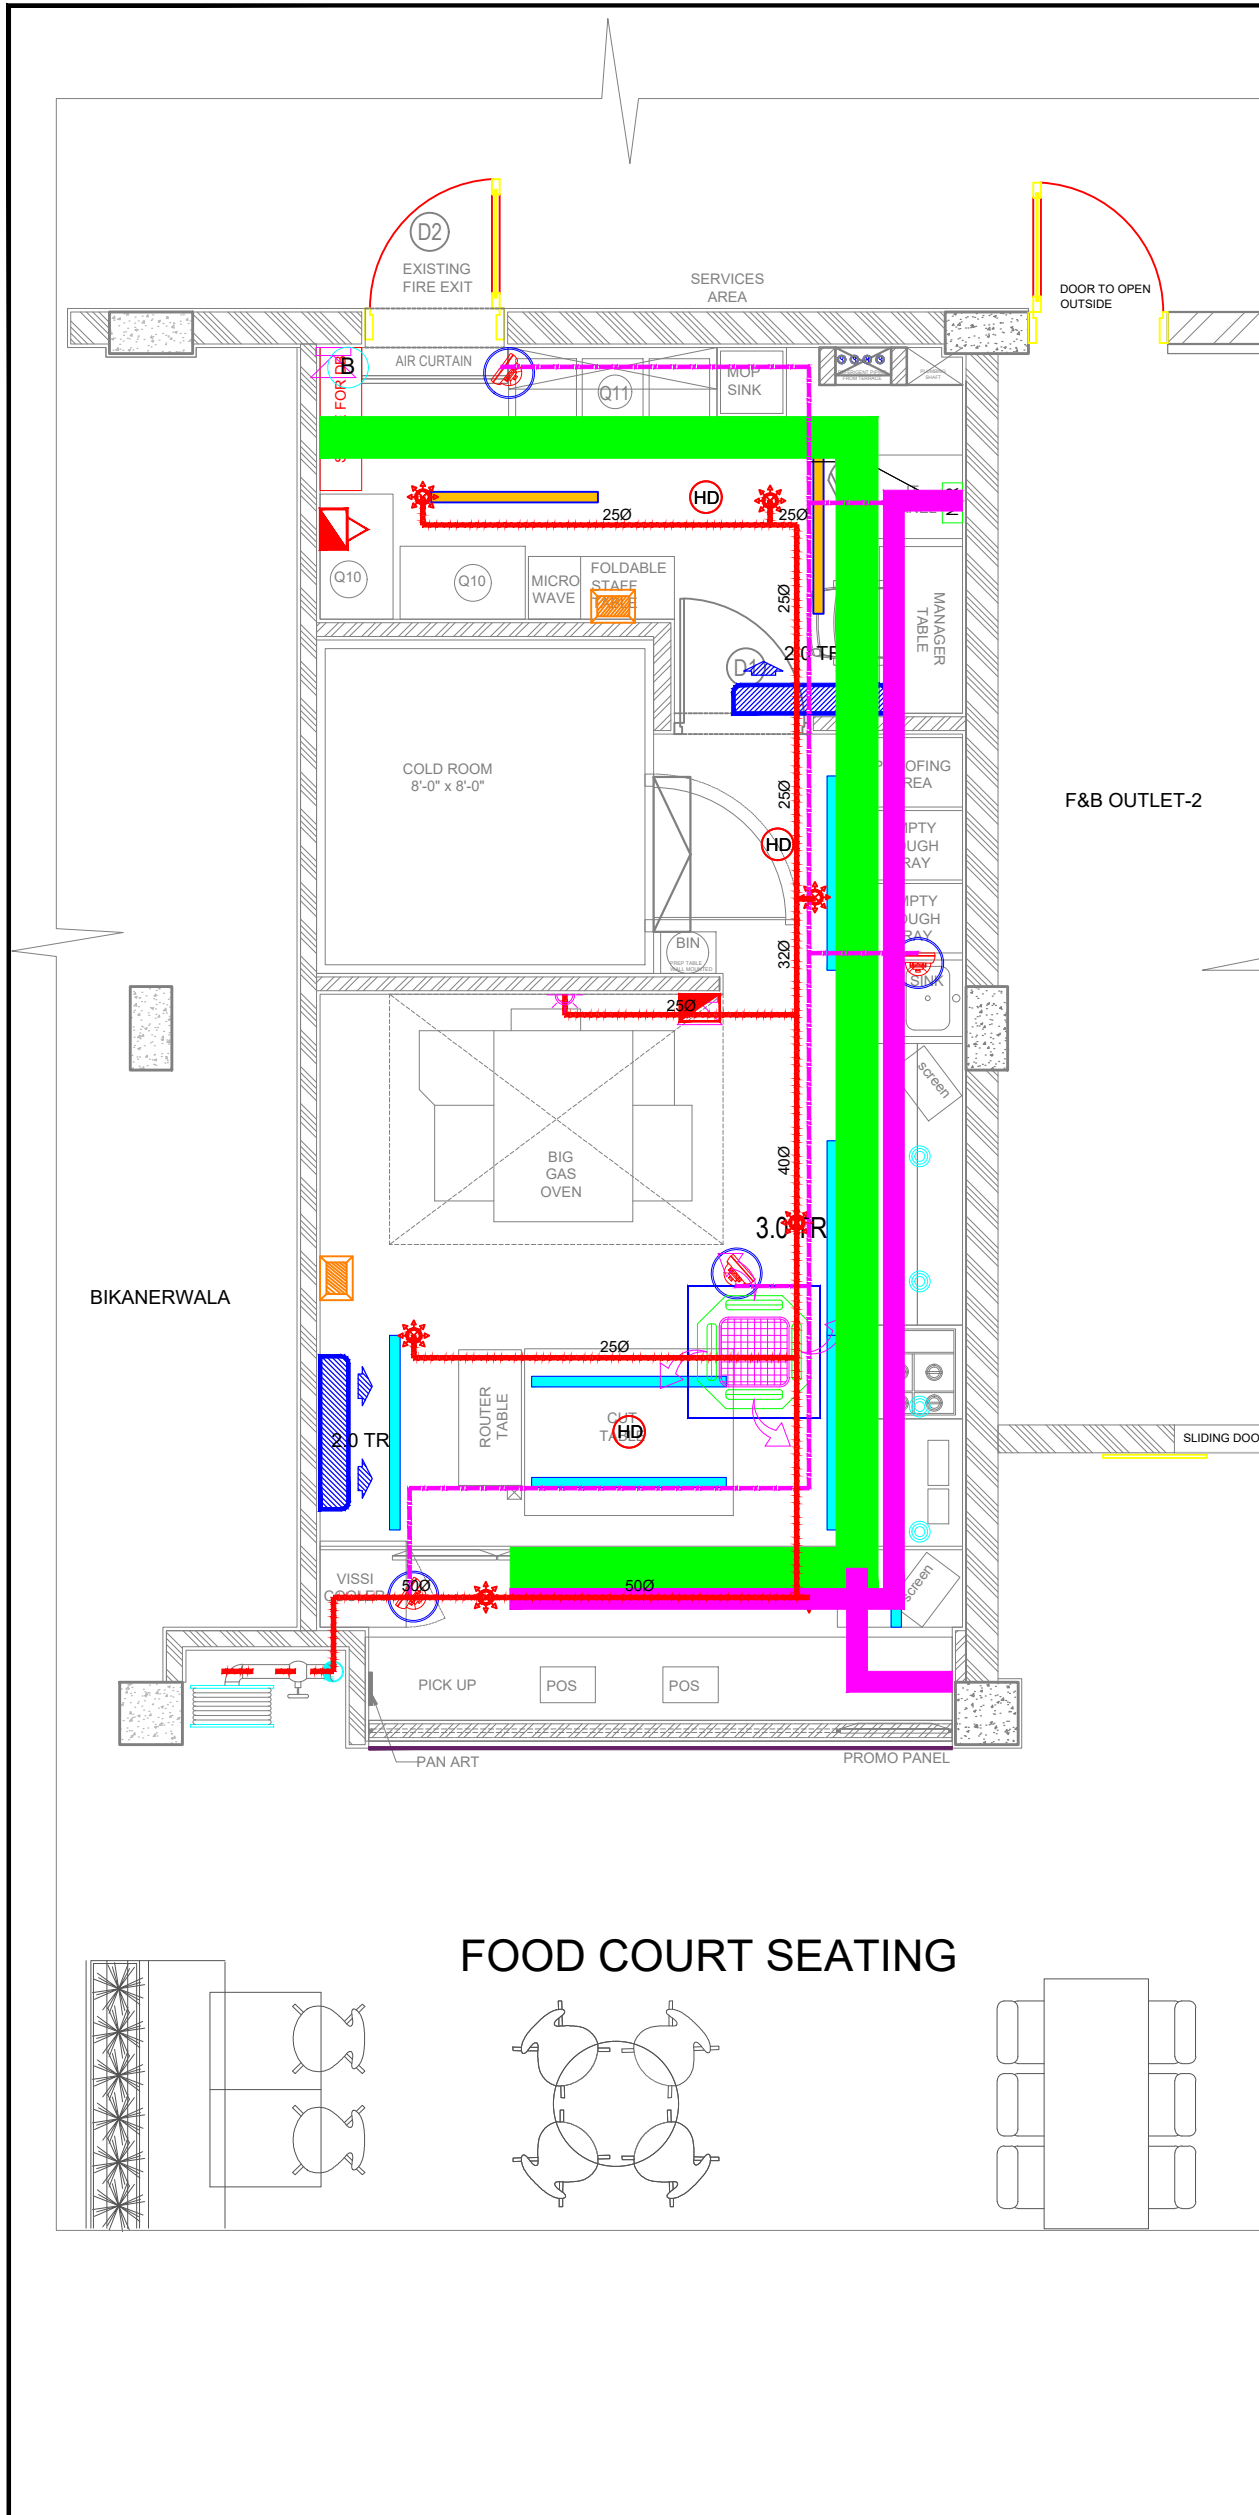

SYM	DESCRIPTION
	SMOKE DETECTOR
	ABOVE SMOKE DETECTOR
	HEAT DETECTOR
	RESPONSE INDICATOR
	SIREN/HOOTER
	MANUAL CALL POINT
	FIRE ALARM CONTROL PANEL
	2x1.5mm2 YYY CABLE

LEGEND	
	300mm x 50mm GI Trunking - Power
	50mm x 50mm GI Trunking - Power/Data
	150mm x 50mm GI Trunking - Lighting/AC


SYM	DESCRIPTION
	CAMERA
	NETWORK VIDEO RECORDING
	CAT 6 WIRE

LEGEND - FIRE FIGHTING	
	SPRINKLER PIPE
	PENDENT TYPE SPRINKLER
	SIDE WALL TYPE SPRINKLER
	BUTTERFLY VALVE
	FLOW SWITCH
	BALL VALVE
	SIGHT GLASS
	DRAIN PIPE
	5KG ABC TYPE EXTINGUISHER
	5KG CO2 TYPE EXTINGUISHER

SYM	DESCRIPTION
	SPEAKER
	AMPLIFIER
	Cable Spec. = 2 Core 1 SQ.MM Cable

LEGEND			
SYMBOL	REP. IMAGES	QTY	ARTICLE NO. PRODUCT-DESCRIPTION
		00	36 W PROFILE LIGHT FOR KITCHEN IN 1000 BELL WITH 40 WATT WITH 1.8M BOWBAR LENGTH OF 1.2 METERS IN 100% OF GUARANTEE WITH 100% HULL COATING OF 0.12 IN 100 WATT FINISHED WITH BLACK POWDER COATING
		00	PROFILE LIGHT FOR ABOVE COUNTER TOP IN 1000 BELL WITH 40 WATT WITH 1.8M BOWBAR LENGTH OF 1.2 METERS IN 100% OF GUARANTEE WITH 100% HULL COATING OF 0.12 IN 100 WATT FINISHED WITH BLACK POWDER COATING
		00	LENGTH OF PROFILE - MAIN COUNTER LEVEL AREA
		01	AIR CURTAIN AS PER APPROVED
		00	CCTV CAMERA
		00	1200 WATT LIGHT FIXTURE WITH 1.8M BOWBAR LENGTH OF 1.2 METERS IN 100% OF GUARANTEE WITH 100% HULL COATING OF 0.12 IN 100 WATT FINISHED WITH BLACK POWDER COATING
		00	9 W WALL WASHER IN 1000 BELL WITH 1000MM INTERNAL ARTICLED IN WALL MOUNTING
		00	18 W WALL WASHER IN 1000 BELL WITH 1000MM INTERNAL ARTICLED IN WALL MOUNTING
		00	36 TRACK
		00	2M TRACK OF 200
		00	40 PER 200 WATT WITH 1.8M BOWBAR LENGTH OF 1.2 METERS IN 100% OF GUARANTEE WITH 100% HULL COATING OF 0.12 IN 100 WATT FINISHED WITH BLACK POWDER COATING
		00	DECOMMISSIONED LIGHT AS SET OF 1000MM
		00	CUSTOMER AREA CORAL INCUBATIVE LIGHT AS SET OF 1000MM
		00	SPRINKLER
		00	MANUAL DETECTOR
		02	NORMAL 15 LIGHT
		01	PROFILE LIGHT FOR KITCHEN IN 1000 BELL WITH 40 WATT WITH 1.8M BOWBAR LENGTH OF 1.2 METERS IN 100% OF GUARANTEE WITH 100% HULL COATING OF 0.12 IN 100 WATT FINISHED WITH BLACK POWDER COATING
		00	DECOMMISSIONED LIGHT FOR KITCHEN IN 1000 BELL WITH 40 WATT WITH 1.8M BOWBAR LENGTH OF 1.2 METERS IN 100% OF GUARANTEE WITH 100% HULL COATING OF 0.12 IN 100 WATT FINISHED WITH BLACK POWDER COATING
		00	CYLINDRICAL SURFACE MOUNTED LIGHT IN WAIT
		00	SURFACE MOUNTED SPEAKER
		00	HOOPER ABOVE 80"
		00	SPEAKER ABOVE 80"
		E	EMERGENCY LIGHT
		00	CYLINDER SURFACE MOUNTED LIGHT IN WAIT (WASHER CONSTRUCTION)
		00	CYLINDER SURFACE MOUNTED LIGHT IN WAIT (WASHER CONSTRUCTION)
		0	PROPOSED NEW 4 LIGHT WITH 1.8M BOWBAR
		0	PROPOSED NEW CLUSTER OF LIGHTS

FOOD COURT SEATING

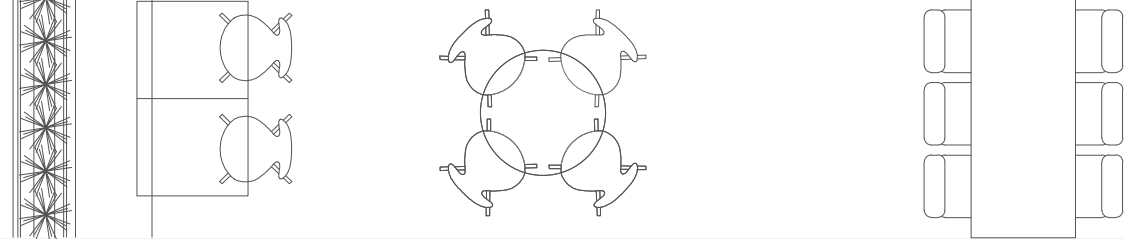

NOTES

1. ALL DIMENSIONS ARE IN MM.
2. ALL LEVELS INDICATED ARE IN MM.
3. DIMENSIONS / LEVELS INDICATED ARE STRUCTURAL UNLESS OTHERWISE SPECIFIED.
4. THIS DRAWING, UNLESS OTHERWISE MENTIONED, TO BE PLOTTED TO STANDARD A1 SIZE.
5. ONLY WRITTEN DIMENSIONS TO BE FOLLOWED. DO NOT SCALE THE DRAWING.
6. DIMENSIONS / LEVELS SHOWN TO BE VERIFIED AT SITE BEFORE COMMENCEMENT OF WORK ANY DISCREPANCIES IF NOTED, SHOULD BE BROUGHT TO THE NOTICE OF ARCHITECT PRIOR TO COMMENCEMENT OF WORK.
7. RELEVANT SERVICES DRAWINGS ARE TO BE READ SIMULTANEOUSLY AND PROVISION OF CUTOUTS/SLEEVES TO BE PROVIDED AS REQUIRED.
8. ALL MATERIALS / FINISHES TO BE AS SPECIFIED AND APPROVED BY THE CONSULTANTS.

CLIENT:

PURPOSE OF RELEASE: AAMIR


MEP CONSULTANTS: CRESCENT ENGINEERS

PROJECT: KHALGHAT - MP

ARCHITECTS & INTERIOR SCENARIES
23/08, KALPANA ENCLAVE, S.N. ROAD, ANDHERI (E), MUMBAI 400 082 TEL: 99 22 94 2103

DWG NO.	142-24 / 112	R0	00
DRAWING:	RCP PLAN		
DRAWN BY:	CHKD BY:	SCALE:	DATE:
SAJJAD	GAUTAMI	1:50	05/03/2024

THIS DRAWING IS THE SOLE PROPERTY OF STUDIO SQUARE IT'S USE FOR ANY PURPOSE OTHER THAN THAT MENTIONED IS TO BE DONE ONLY AFTER PRIOR APPROVAL.

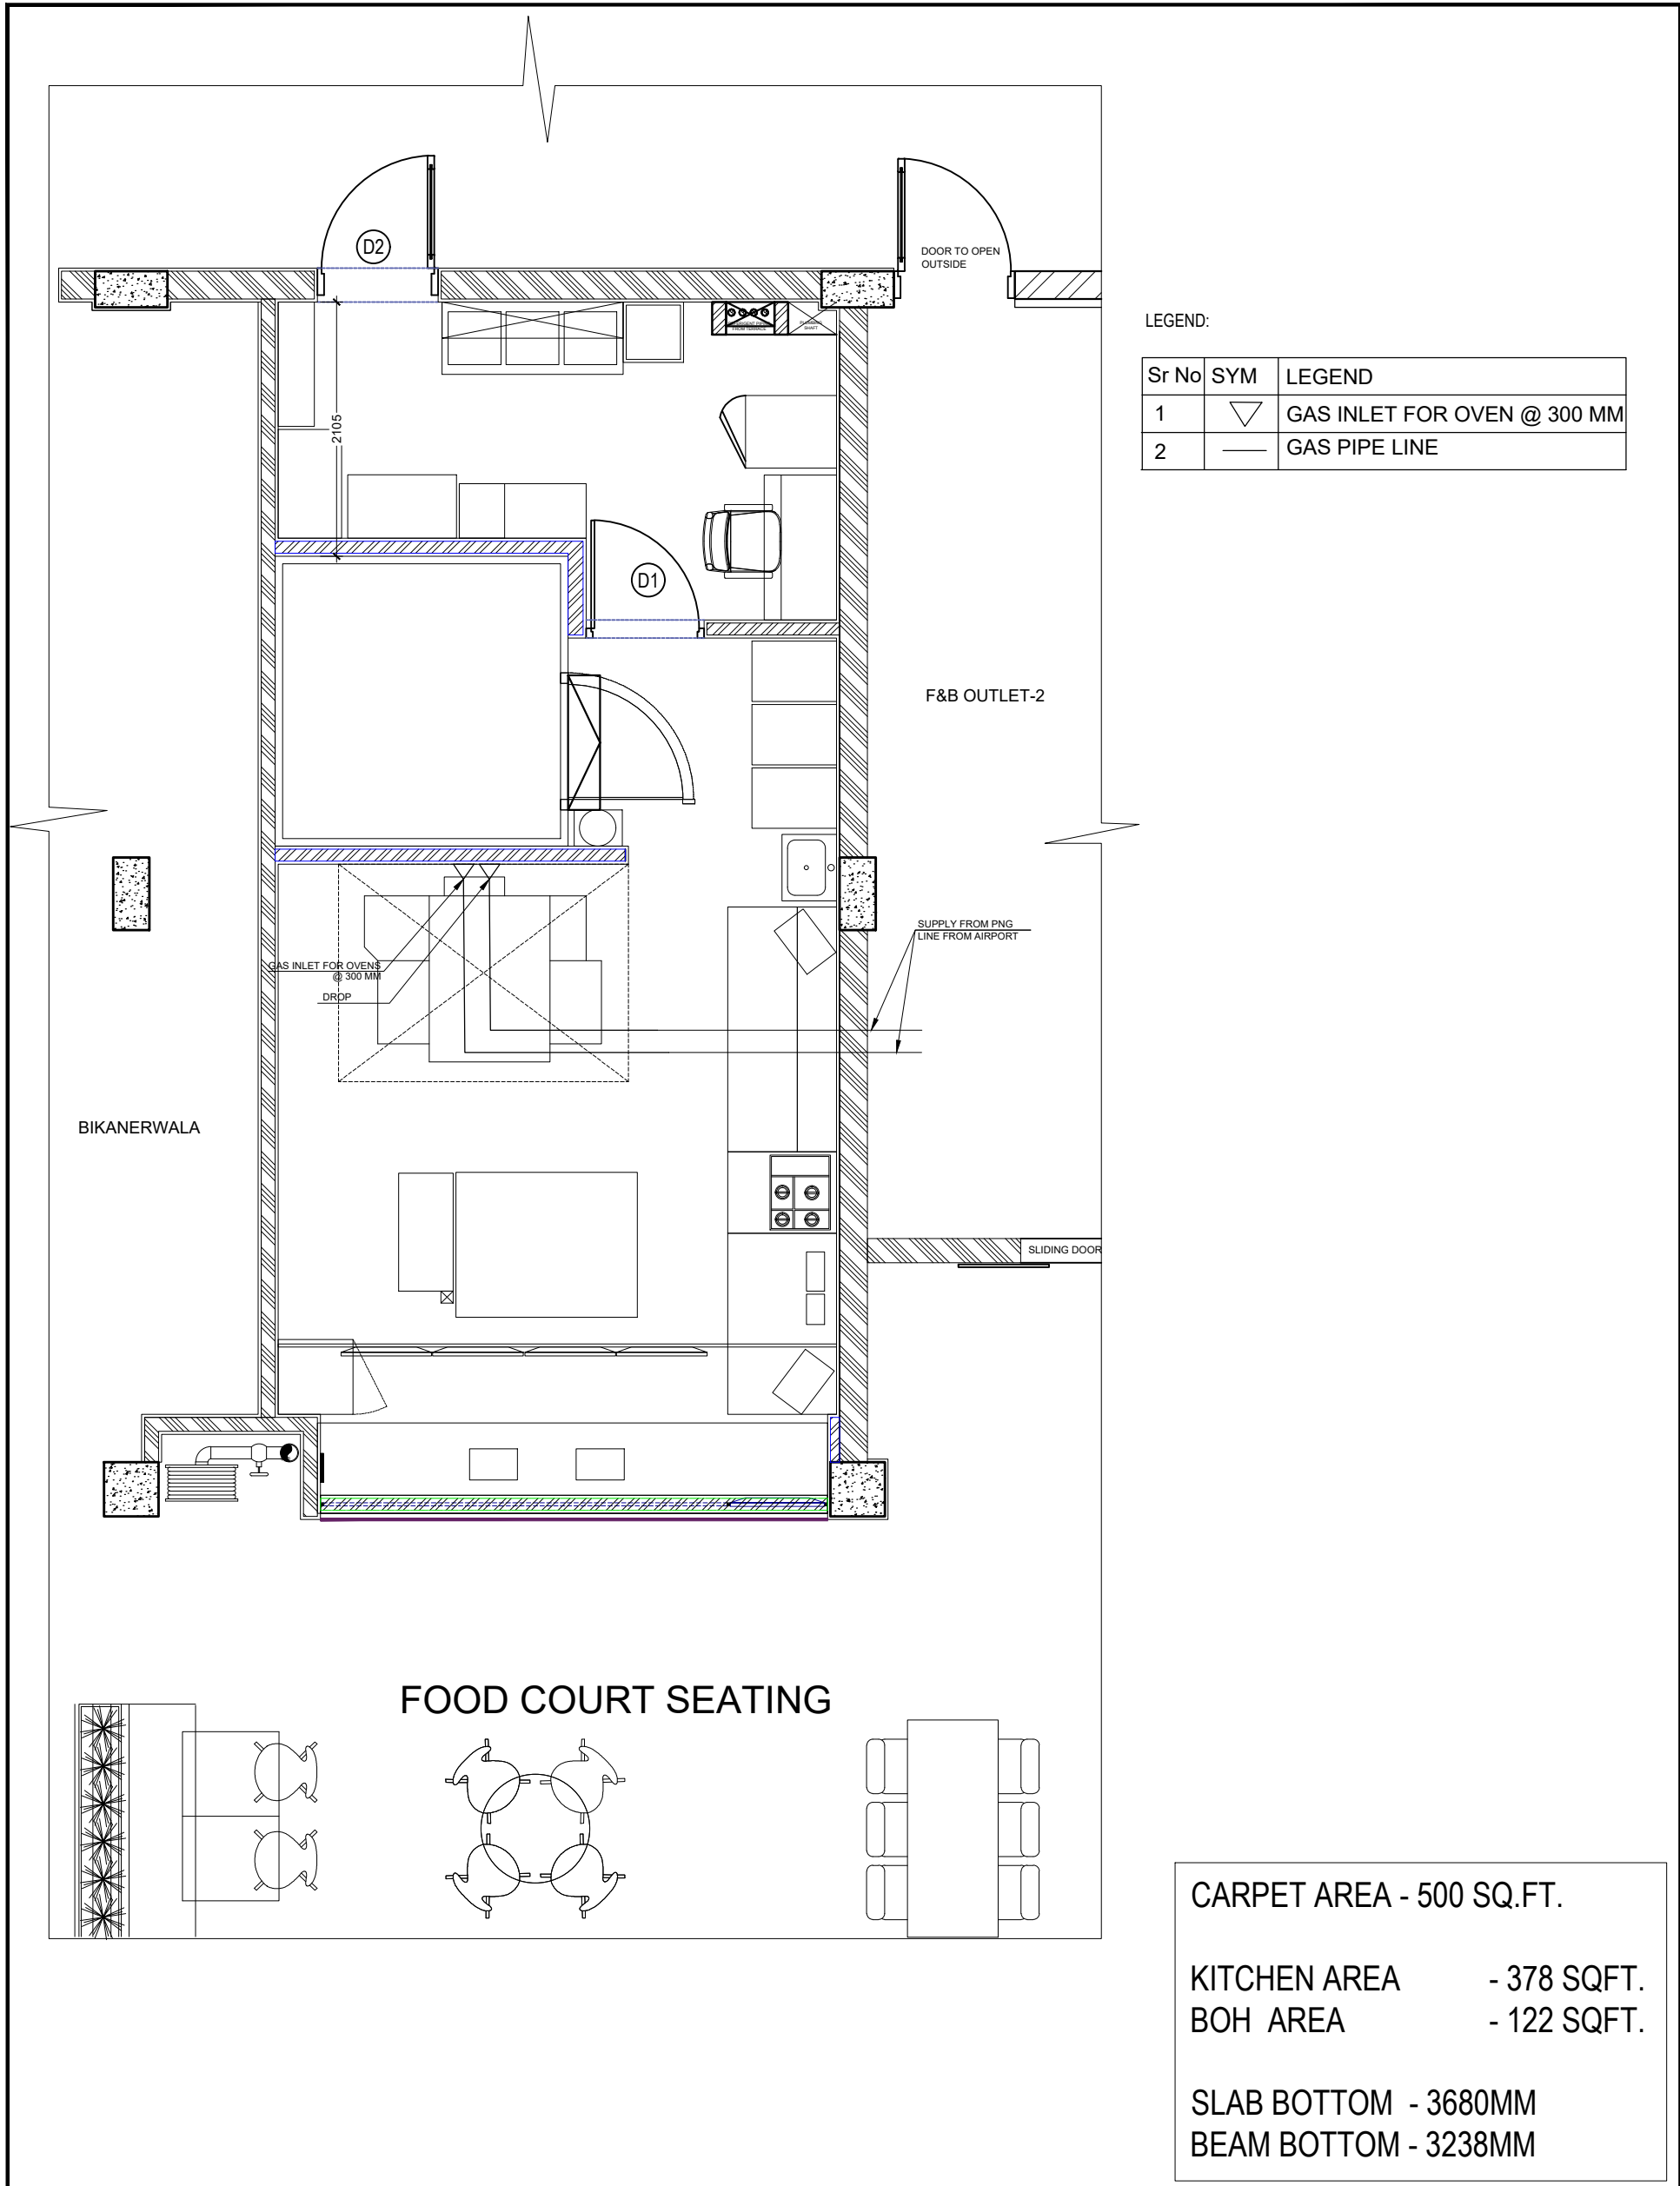

LEGEND:


Sr No	SYM	LEGEND
1	▽	GAS INLET FOR OVEN @ 300 MM
2	—	GAS PIPE LINE

CARPET AREA - 500 SQ.FT.
 KITCHEN AREA - 378 SQFT.
 BOH AREA - 122 SQFT.
 SLAB BOTTOM - 3680MM
 BEAM BOTTOM - 3238MM

NOTES

1. ALL DIMENSIONS ARE IN MM.
2. ALL LEVELS INDICATED ARE IN MM.
3. DIMENSIONS / LEVELS INDICATED ARE STRUCTURAL UNLESS OTHER SPECIFIED.
4. THIS DRAWING, UNLESS OTHERWISE MENTIONED, TO BE PLOTTED TO STANDARD A1 SIZE.
5. ONLY WRITTEN DIMENSIONS TO BE FOLLOWED. DO NOT SCALE THE DRAWING
6. DIMENSIONS / LEVELS SHOWN TO BE VERIFIED AT SITE BEFORE COMMENCEMENT OF WORK ANY DISCREPANCIES IF NOTED, SHOULD BE BROUGHT TO THE NOTICE OF ARCHITECT PRIOR TO COMMENCEMENT OF WORK.
7. RELEVANT SERVICES DRAWINGS ARE TO BE READ SIMULTANEOUSLY AND PROVISION OF CUTOUTS/SLEEVES TO BE PROVIDED AS REQUIRED.
8. ALL MATERIALS / FINISHES TO BE AS SPECIFIED AND APPROVED BY THE CONSULTANTS.


CLIENT:



PURPOSE OF RELEASE
RINK MALL-DARJEELING

MEP CONSULTANTS:
CRESCENT ENGINEERS

PROJECT
KHALGHAT - MP




DWG NO.	142-24 / 193	R0	00
DRAWING:	GASS BANK PLAN		
DRAWN BY:	CHKD BY:	SCALE:	DATE:
SAJJAD	AAMIR	1:50	05/03/2024

THIS DRAWING IS THE SOLE PROPERTY OF STUDIO SQUARE IT'S USE FOR ANY PURPOSE OTHER THAN THAT MENTIONED IS TO BE DONE ONLY AFTER PRIOR APPROVAL.


WATER SUPPLY

LEGEND: - WATER SUPPLY

SYM	DESCRIPTION
	DOMESTIC WATER SUPPLY PIPE
	FLUSHING WATER SUPPLY PIPE
	DOMESTIC WATER SUPPLY CPVC PIPE
	FLUSHING WATER SUPPLY CPVC PIPE
	RO WATER CPVC SUPPLY
	INLET TO STORAGE TANK
	BALL VALVE
	FLOW DIRECTION
AC.	ANGLE COCK
BV.	BALL VALVE
AG.	AQUA GUARD
WT.	WATER TAPPING
	GYSER

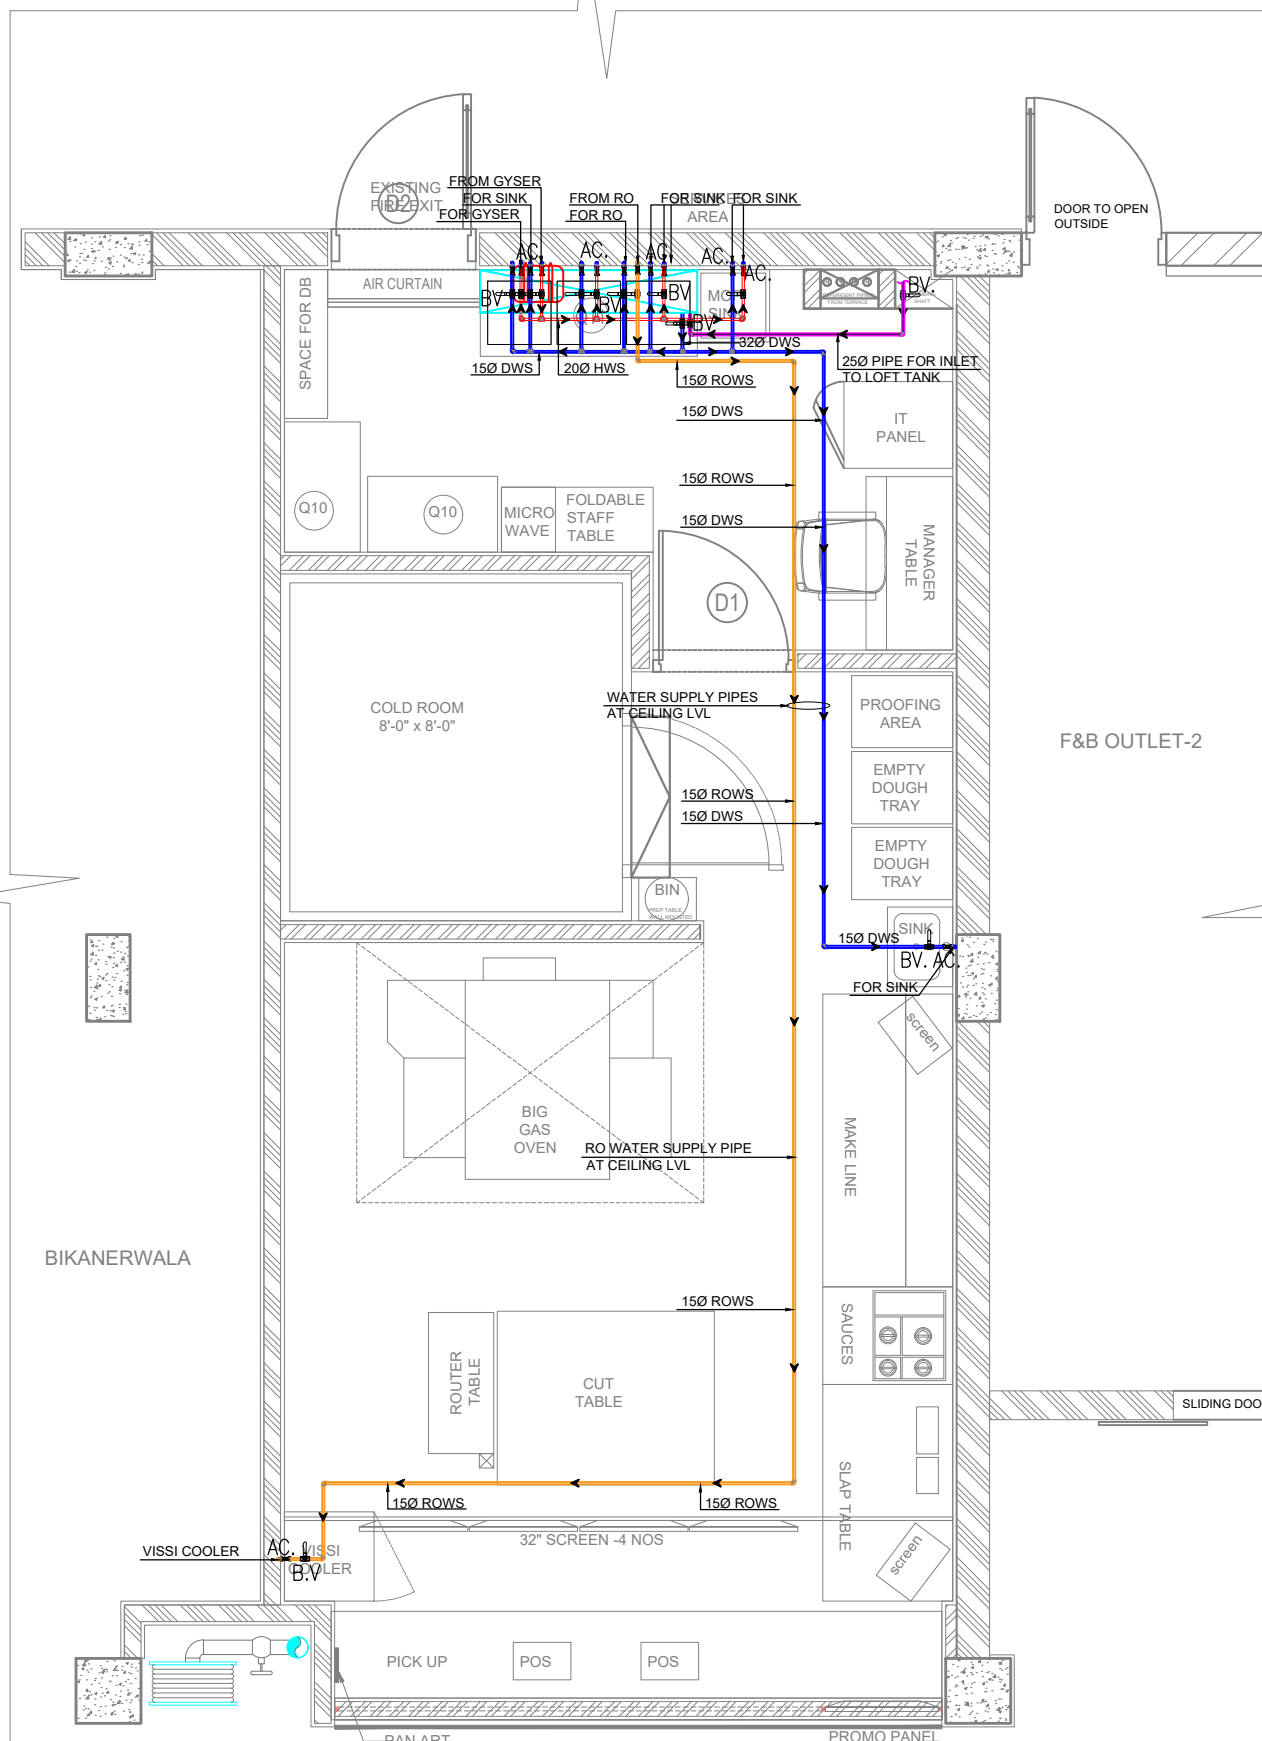

FOOD COURT SEATING

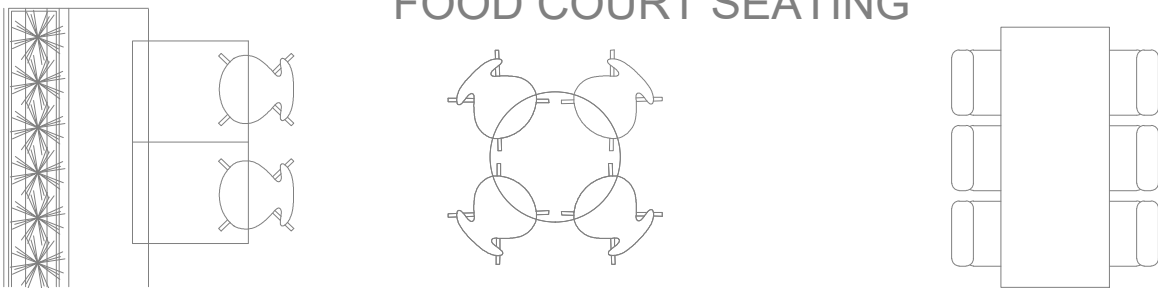

CARPET AREA - 500 SQ.FT.

KITCHEN AREA - 378 SQFT.

BOH AREA - 122 SQFT.

SLAB BOTTOM - 3680MM

BEAM BOTTOM - 3238MM

NOTES

1. ALL DIMENSIONS ARE IN MM.
2. ALL LEVELS INDICATED ARE IN MM.
3. DIMENSIONS / LEVELS INDICATED ARE STRUCTURAL UNLESS OTHERWISE SPECIFIED.
4. THIS DRAWING, UNLESS OTHERWISE MENTIONED, TO BE PLOTTED TO STANDARD A1 SIZE.
5. ONLY WRITTEN DIMENSIONS TO BE FOLLOWED. DO NOT SCALE THE DRAWING.
6. DIMENSIONS / LEVELS SHOWN TO BE VERIFIED AT SITE BEFORE COMMENCEMENT OF WORK ANY DISCREPANCIES IF NOTED, SHOULD BE BROUGHT TO THE NOTICE OF ARCHITECT PRIOR TO COMMENCEMENT OF WORK.
7. RELEVANT SERVICES DRAWINGS ARE TO BE READ SIMULTANEOUSLY AND PROVISION OF CUTOUTS/SLEEVES TO BE PROVIDED AS REQUIRED.
8. ALL MATERIALS / FINISHES TO BE AS SPECIFIED AND APPROVED BY THE CONSULTANTS.

CLIENT:



PURPOSE OF RELEASE
RINK MALL-DARJEELING

MEP CONSULTANTS:
CRESCENT ENGINEERS

PROJECT
KHALGHAT - MP



DWG NO.

142-24 / 191

R0

DRAWING:

WATER SUPPLY PLAN

00

DRAWN BY:

CHKD BY:

SCALE:

DATE:

ASIM

AAMIR

1:50


05/03/2024

THIS DRAWING IS THE SOLE PROPERTY OF STUDIO SQUARE IT'S USE FOR ANY PURPOSE OTHER THAN THAT MENTIONED IS TO BE DONE ONLY AFTER PRIOR APPROVAL.


DRAINAGE

LEGEND: -DRAINAGE

SYM	DESCRIPTION
	DOMESTIC WATER SUPPLY PIPE
	FLUSHING WATER SUPPLY PIPE
	100Ø SOIL UPVC PIPE
	75Ø WASTE UPVC PIPE
	32Ø WASTE UPVC PIPE
	MULTIPLE TRAP
	900X450MM INSPECTION CHAMBER
	300X300MM GULLY TRAP

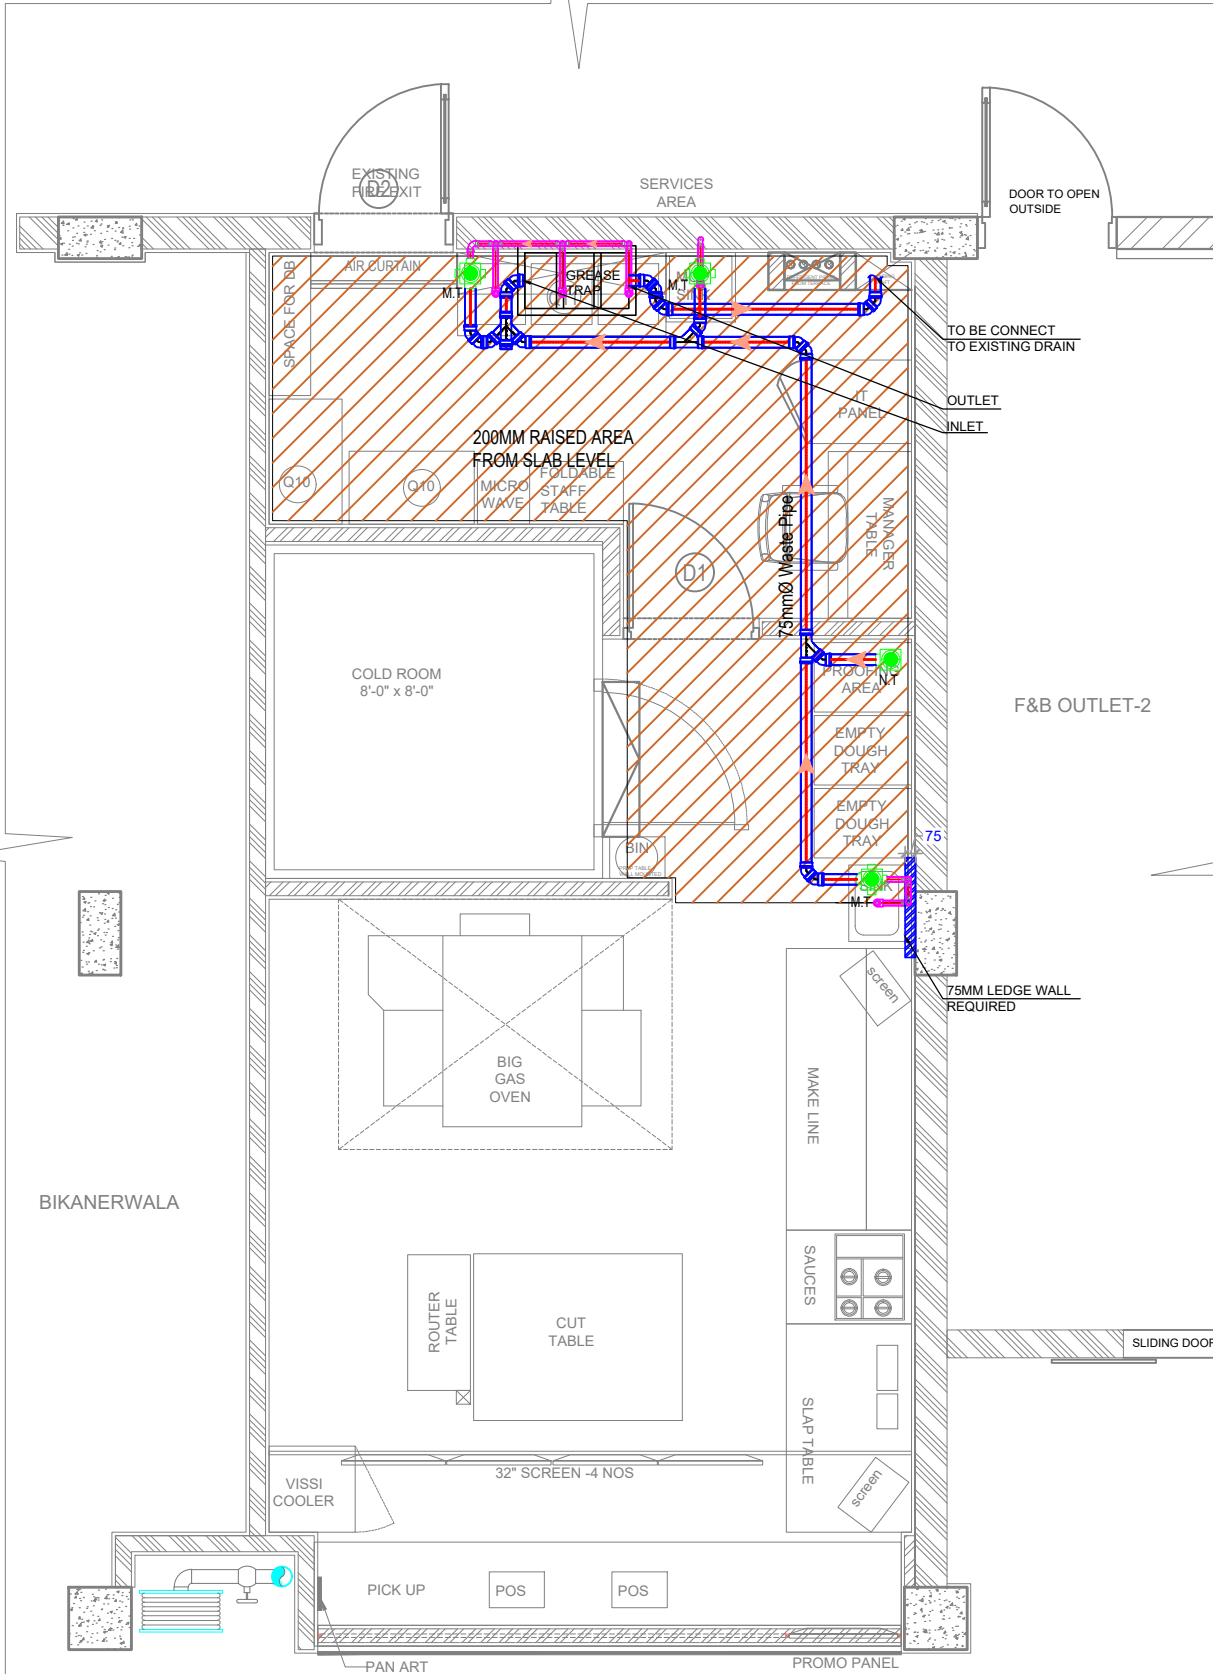

FOOD COURT SEATING

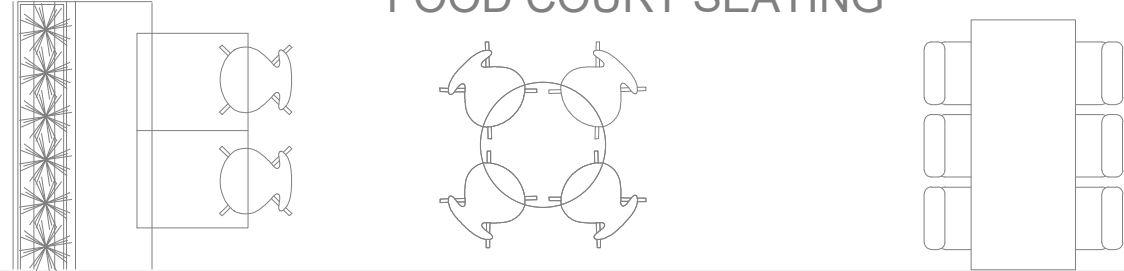

CARPET AREA - 500 SQ.FT.	
KITCHEN AREA	- 378 SQFT.
BOH AREA	- 122 SQFT.
SLAB BOTTOM	- 3680MM
BEAM BOTTOM	- 3238MM

NOTES

1. ALL DIMENSIONS ARE IN MM.
2. ALL LEVELS INDICATED ARE IN MM.
3. DIMENSIONS / LEVELS INDICATED ARE STRUCTURAL UNLESS OTHERWISE SPECIFIED.
4. THIS DRAWING, UNLESS OTHERWISE MENTIONED, TO BE PLOTTED TO STANDARD A1 SIZE.
5. ONLY WRITTEN DIMENSIONS TO BE FOLLOWED. DO NOT SCALE THE DRAWING.
6. DIMENSIONS / LEVELS SHOWN TO BE VERIFIED AT SITE BEFORE COMMENCEMENT OF WORK ANY DISCREPANCIES IF NOTED, SHOULD BE BROUGHT TO THE NOTICE OF ARCHITECT PRIOR TO COMMENCEMENT OF WORK.
7. RELEVANT SERVICES DRAWINGS ARE TO BE READ SIMULTANEOUSLY AND PROVISION OF CUTOUTS/SLEEVES TO BE PROVIDED AS REQUIRED.
8. ALL MATERIALS / FINISHES TO BE AS SPECIFIED AND APPROVED BY THE CONSULTANTS.

CLIENT:



PURPOSE OF RELEASE
RINK MALL-DARJEELING
MEP CONSULTANTS:
CRESCENT ENGINEERS
PROJECT
KHALGHAT - MP




DWG NO.	142-24 / 192	R0	00
DRAWING:	DRAINAGE PLAN		
DRAWN BY:	CHKD BY:	SCALE:	DATE:
ASIM	AAMIR	1:50	05/032024



THIS DRAWING IS THE SOLE PROPERTY OF STUDIO SQUARE IT'S USE FOR ANY PURPOSE OTHER THAN THAT MENTIONED IS TO BE DONE ONLY AFTER PRIOR APPROVAL.

LEGEND: -FIRE FIGHTING

SYM	DESCRIPTION
	SPRINKLER PIPE
	PENDENT TYPE SPRINKLER
	SIDE WALL TYPE SPRINKLER
	BUTTERFLY VALVE
	FLOW SWITCH
	BALL VALVE
	SIGHT GLASS
	DRAIN PIPE
	5KG ABC TYPE EXTINGUISHER
	5KG CO2 TYPE EXTINGUISHER

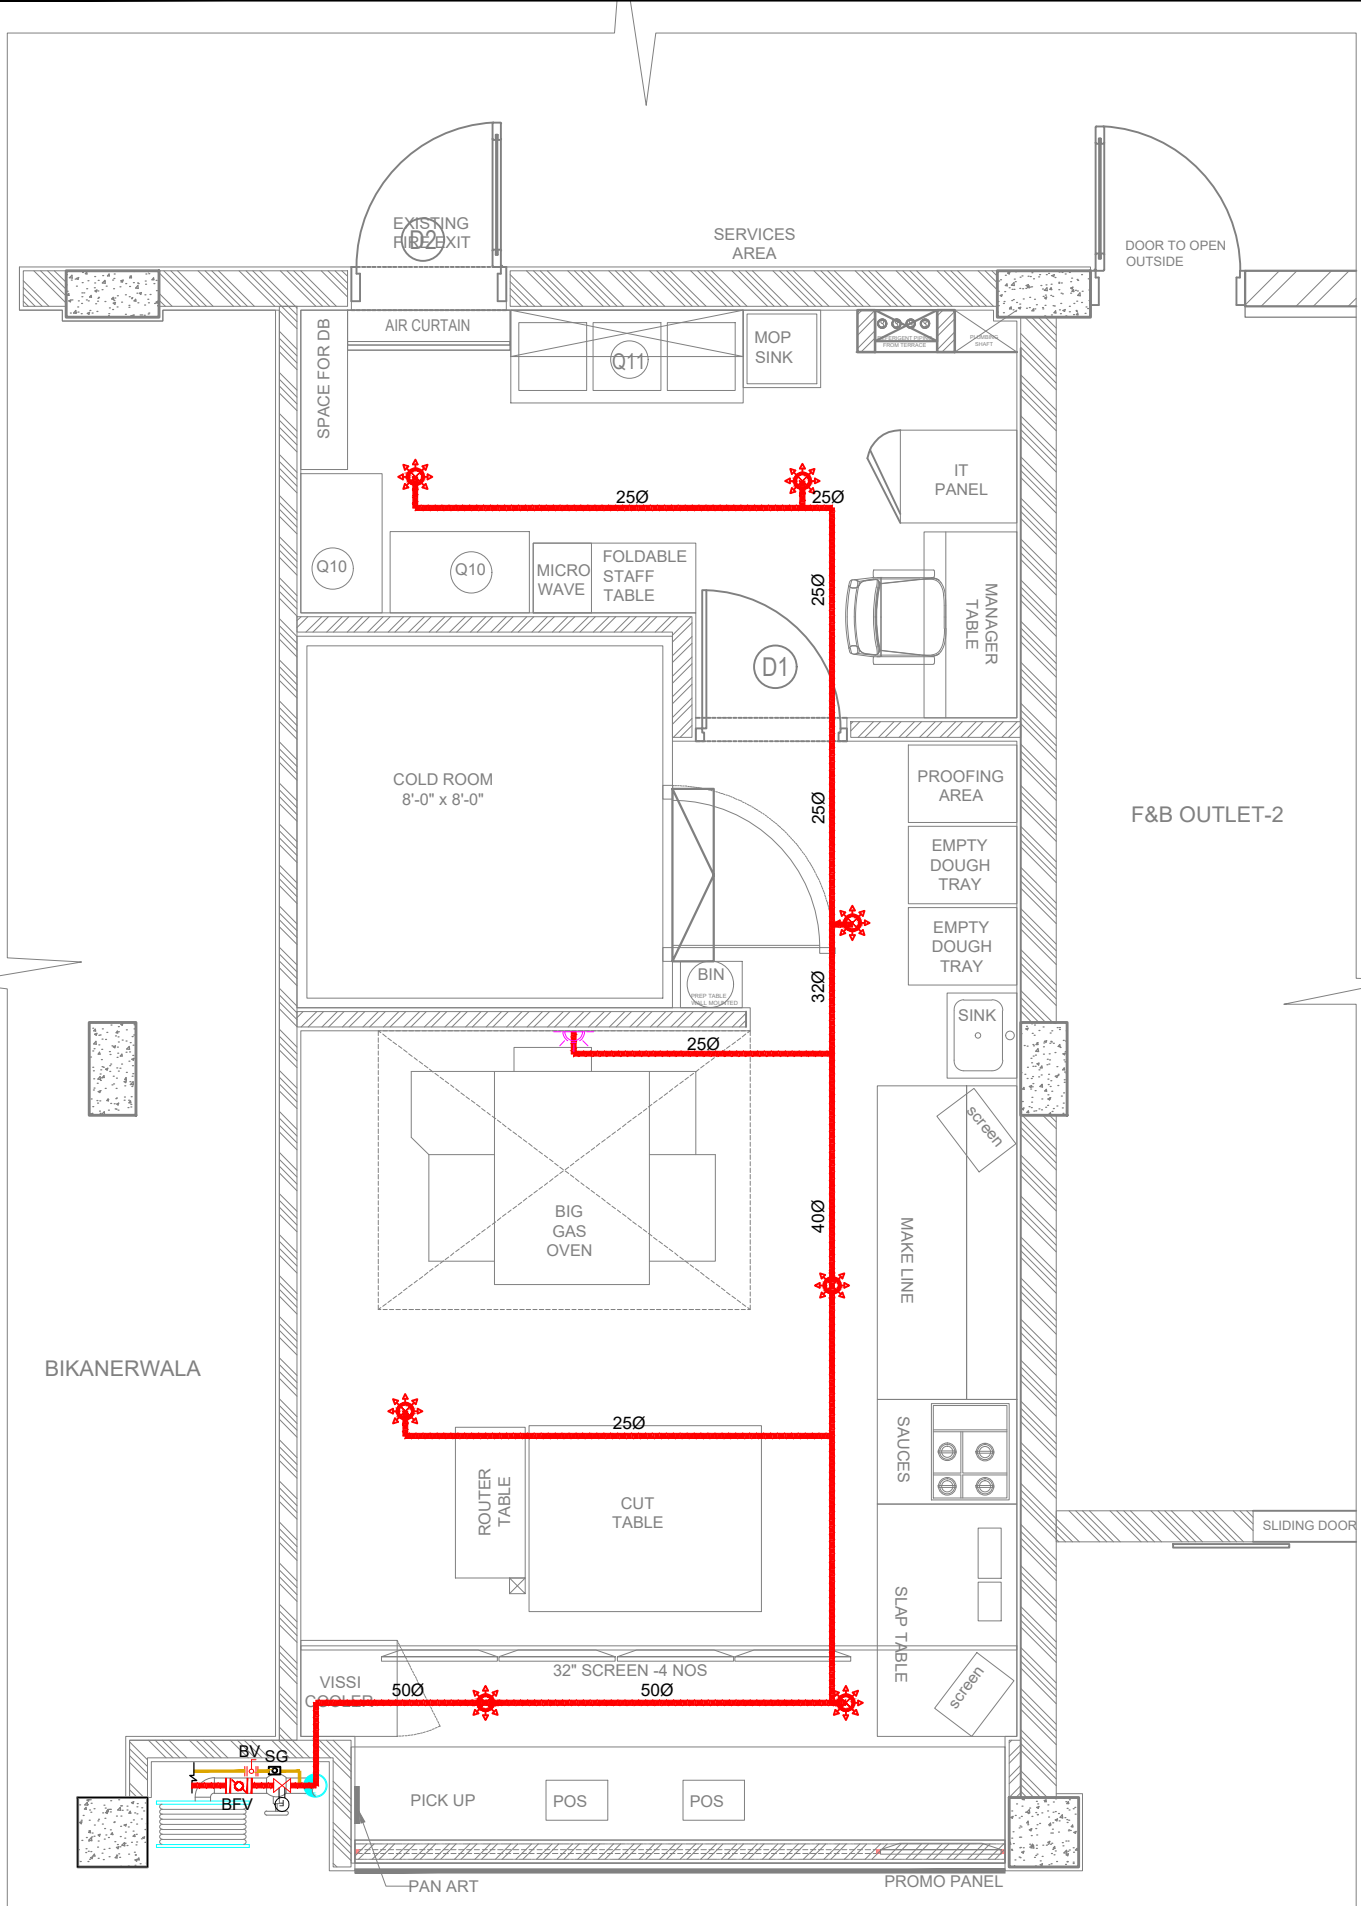

FOOD COURT SEATING

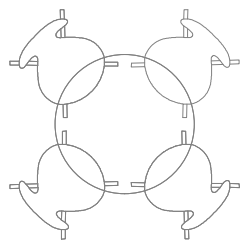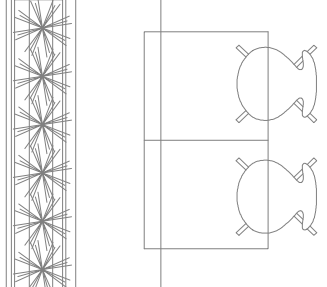

CARPET AREA - 500 SQ.FT.
 KITCHEN AREA - 378 SQFT.
 BOH AREA - 122 SQFT.
 SLAB BOTTOM - 3680MM
 BEAM BOTTOM - 3238MM

NOTES

- 1.ALL DIMENSIONS ARE IN MM.
- 2.ALL LEVELS INDICATED ARE IN MM.
- 3.DIMENSIONS / LEVELS INDICATED ARE STRUCTURAL UNLESS OTHERWISE SPECIFIED.
- 4.THIS DRAWING, UNLESS OTHERWISE MENTIONED, TO BE PLOTTED TO STANDARD A1 SIZE.
- 5.ONLY WRITTEN DIMENSIONS TO BE FOLLOWED.DO NOT SCALE THE DRAWING
- 6.DIMENSIONS / LEVELS SHOWN TO BE VERIFIED AT SITE BEFORE COMMENCEMENT OF WORK ANY DISCREPANCIES IF NOTED, SHOULD BE BROUGHT TO THE NOTICE OF ARCHITECT.PRIOR TO COMMENCEMENT OF WORK.
- 7.RELEVANT SERVICES DRAWINGS ARE TO BE READ SIMULTANEOUSLY AND PROVISION OF CUTOUTS/SLEEVES TO BE PROVIDED AS REQUIRED.
- 8.ALL MATERIALS / FINISHES TO BE AS SPECIFIED AND APPROVED BY THE CONSULTANTS.

CLIENT: **Domino's**

PURPOSE OF RELEASE
 RINK MALL-DARJEELING


MEP CONSULTANTS:
 CRESCENT ENGINEERS

PROJECT
 KHALGHAT - MP


STUDIOSQUARE
 ARCHITECTS & INTERIOR SCENARIES
 23/08, KALPITA ENCLAVE, 81 N. ROAD, ANDHERI (E),
 MUMBAI 400 089 TEL: 99 22 954 2103

DWG NO.	142-24 / 193	R0	00
DRAWING:	FIRE FIGHTING PLAN		
DRAWN BY:	CHKD BY:	SCALE:	DATE:
VARSHA	GAUTAMI	1:50	23/02/2024


THIS DRAWING IS THE SOLE PROPERTY OF STUDIO SQUARE IT'S USE FOR ANY PURPOSE OTHER THAN THAT MENTIONED IS TO BE DONE ONLY AFTER PRIOR APPROVAL.

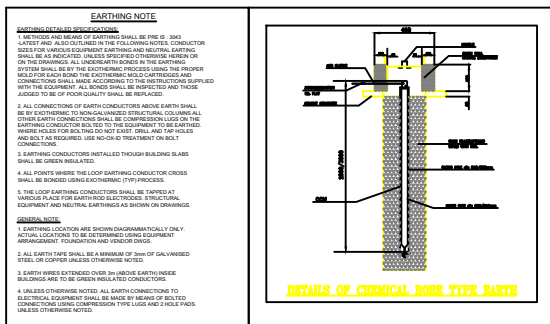

DEDICATED EARTH SCHEMATIC

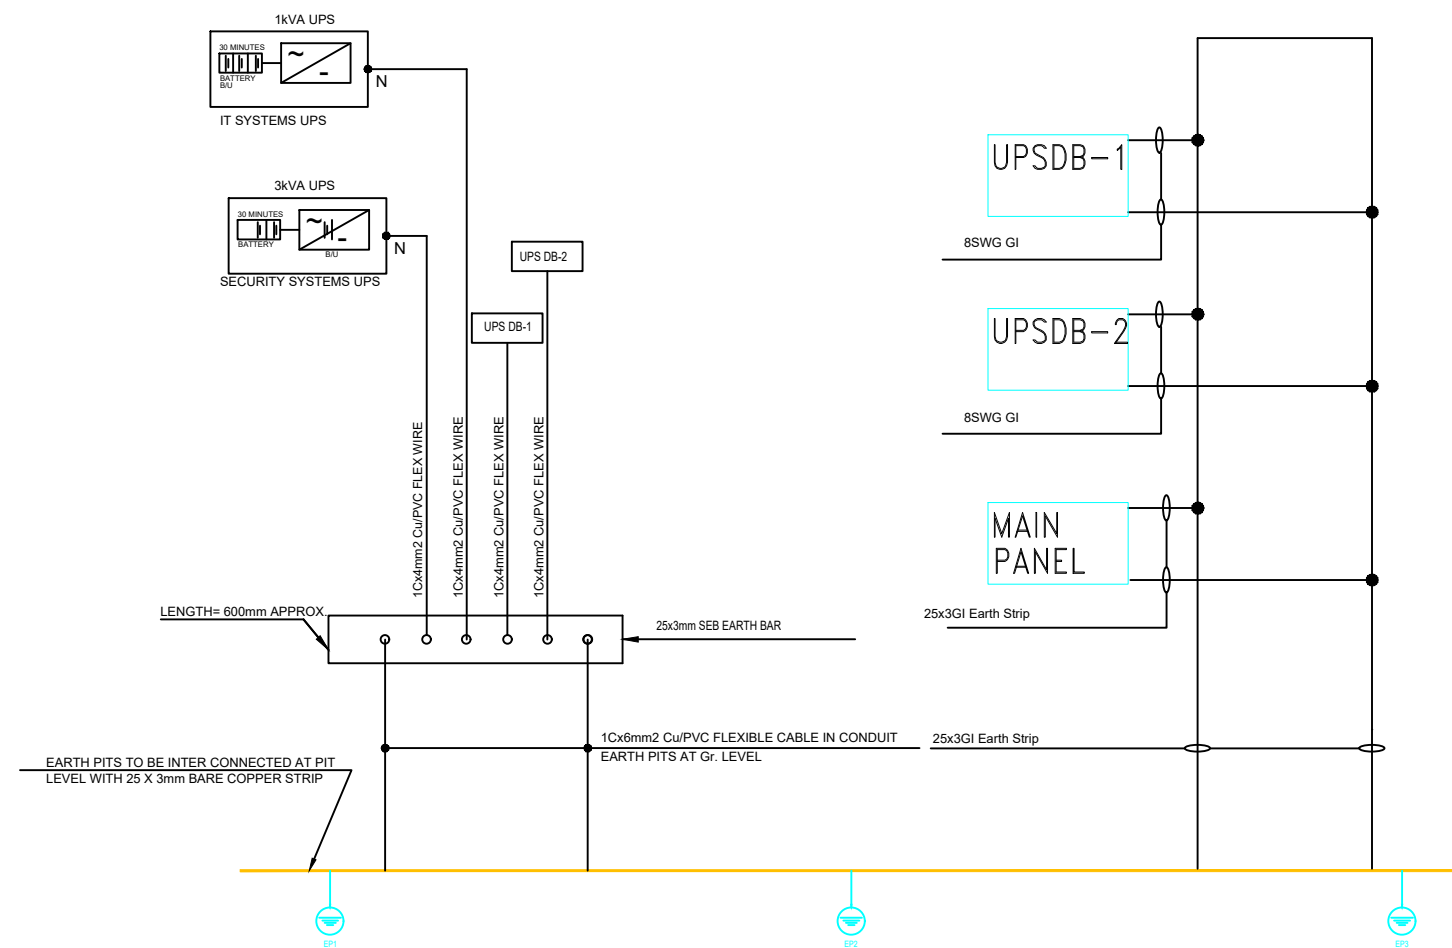

BODY EARTH SCHEMATIC



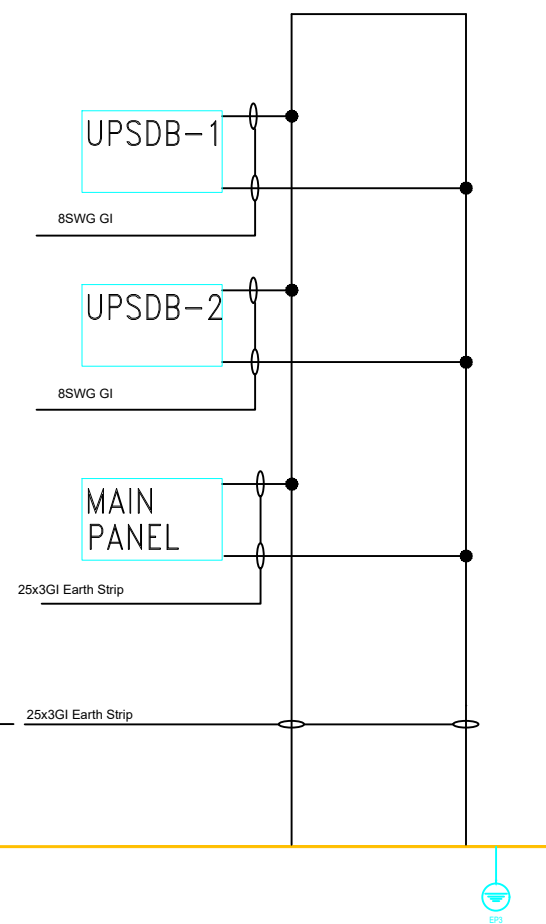


		ISSUED FOR TENDER	
PROJECT DOMINOS KHALGHAT MP		 32/09, KALPITA ENCLAVE, S.N. ROAD, ANDHERI-(E), MUMBAI 400 069 TEL: +91 22 3164 2193	
ARCHITECTS STUDIO SQUARE		TITLE EARTH SCHEMATIC	
SCALE N.T.S.		DRN BY <i>JHB</i>	CHK BY <i>ANH</i>
		DWG.NO 142-22-165	DATE 04/03/2024

SLD FOR DOMINO'S KHALGHAT MP

- NOTES**
1. PANEL SHALL BE FREE STANDING, PLAIN BRONZE FINISH COMPLIANCE/STANDARD, DUST & TERMITES PROOF & IP 4X PROOF.
 2. PULLBOXES : 14/18 DIA. CIRCULAR TYPE, BARE FINISH SHALL BE USED. 200MM DIA.
 3. PULLBOX : SPOT POWER CABLES AFTER 7-DAY CLEANING PERIODS CABLES SHALL BE CHECKED FOR LEAKS, DIRT, MOISTURE.
 4. BATTERIES : BATTERIES CABLES SHALL BE ALUMINUM OR COPPER CONDUCTIVITY TYPE IN BLACK INSULATED SHEATHS CONDUCTIVITY SHEATH = 1.20 A/mm².
 5. BATTERY SUPPORTS : ALL BATTERY TYPE SUPPORTS SHALL BE USED ACCORDING TO SPECIFICATIONS AT 400mm.
 6. CABLES : CABLES SHALL BE CHECKED FOR ALL S.S. & S.S. 304 FOR ALL DIMENSIONS OF PANELS IN ACCORDANCE WITH APPROVALS FROM THE APPLICABLE AUTHORITIES.
 7. ALL MCCB'S TYPE 'T' MARKING SHALL BE THERMAL BOUND BREAK & AIRWORKS.
 8. ALL MCCB SHALL BE 'T' TYPE FOR LIMITED AND POWER SUPPLY.
 9. ALL MCCB SHALL BE 'T' TYPE FOR 1000V.

MAIN PANEL
 Connected Load:- 58.65kW
 Demand Load:- 43.94kW

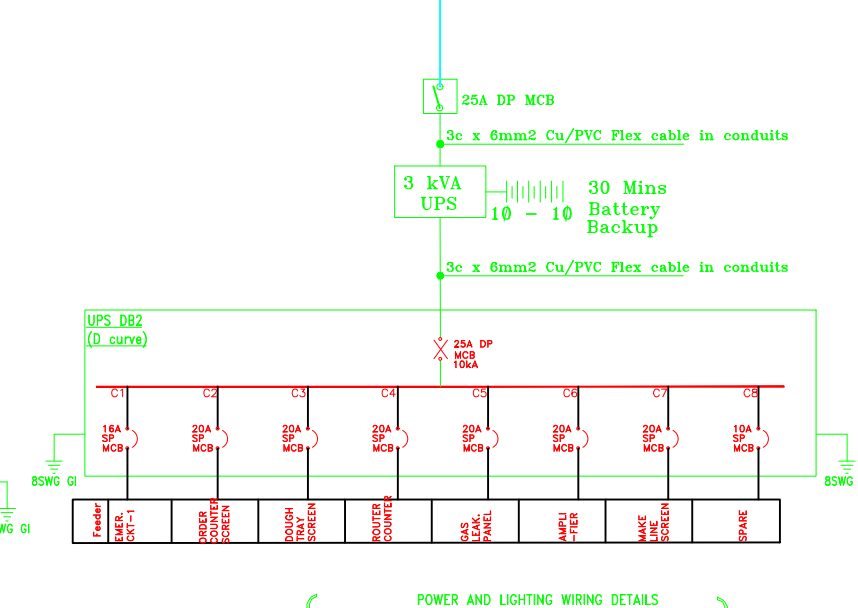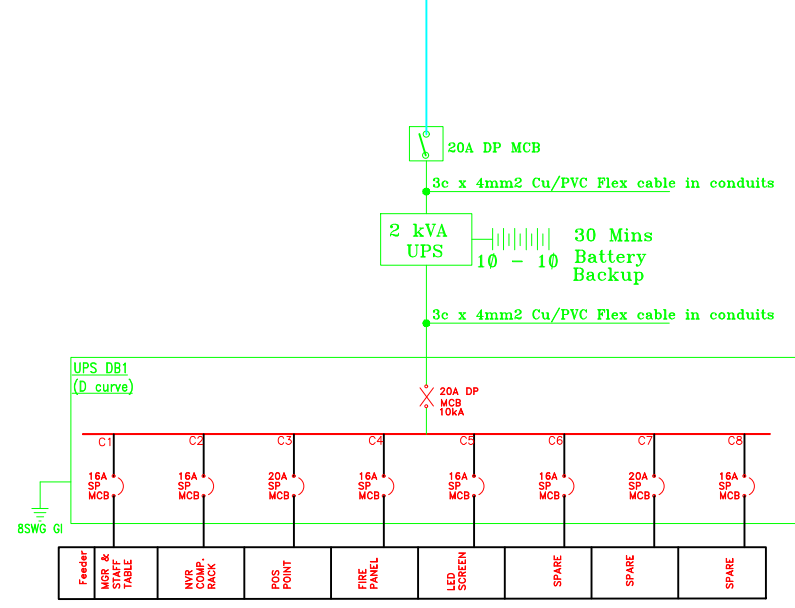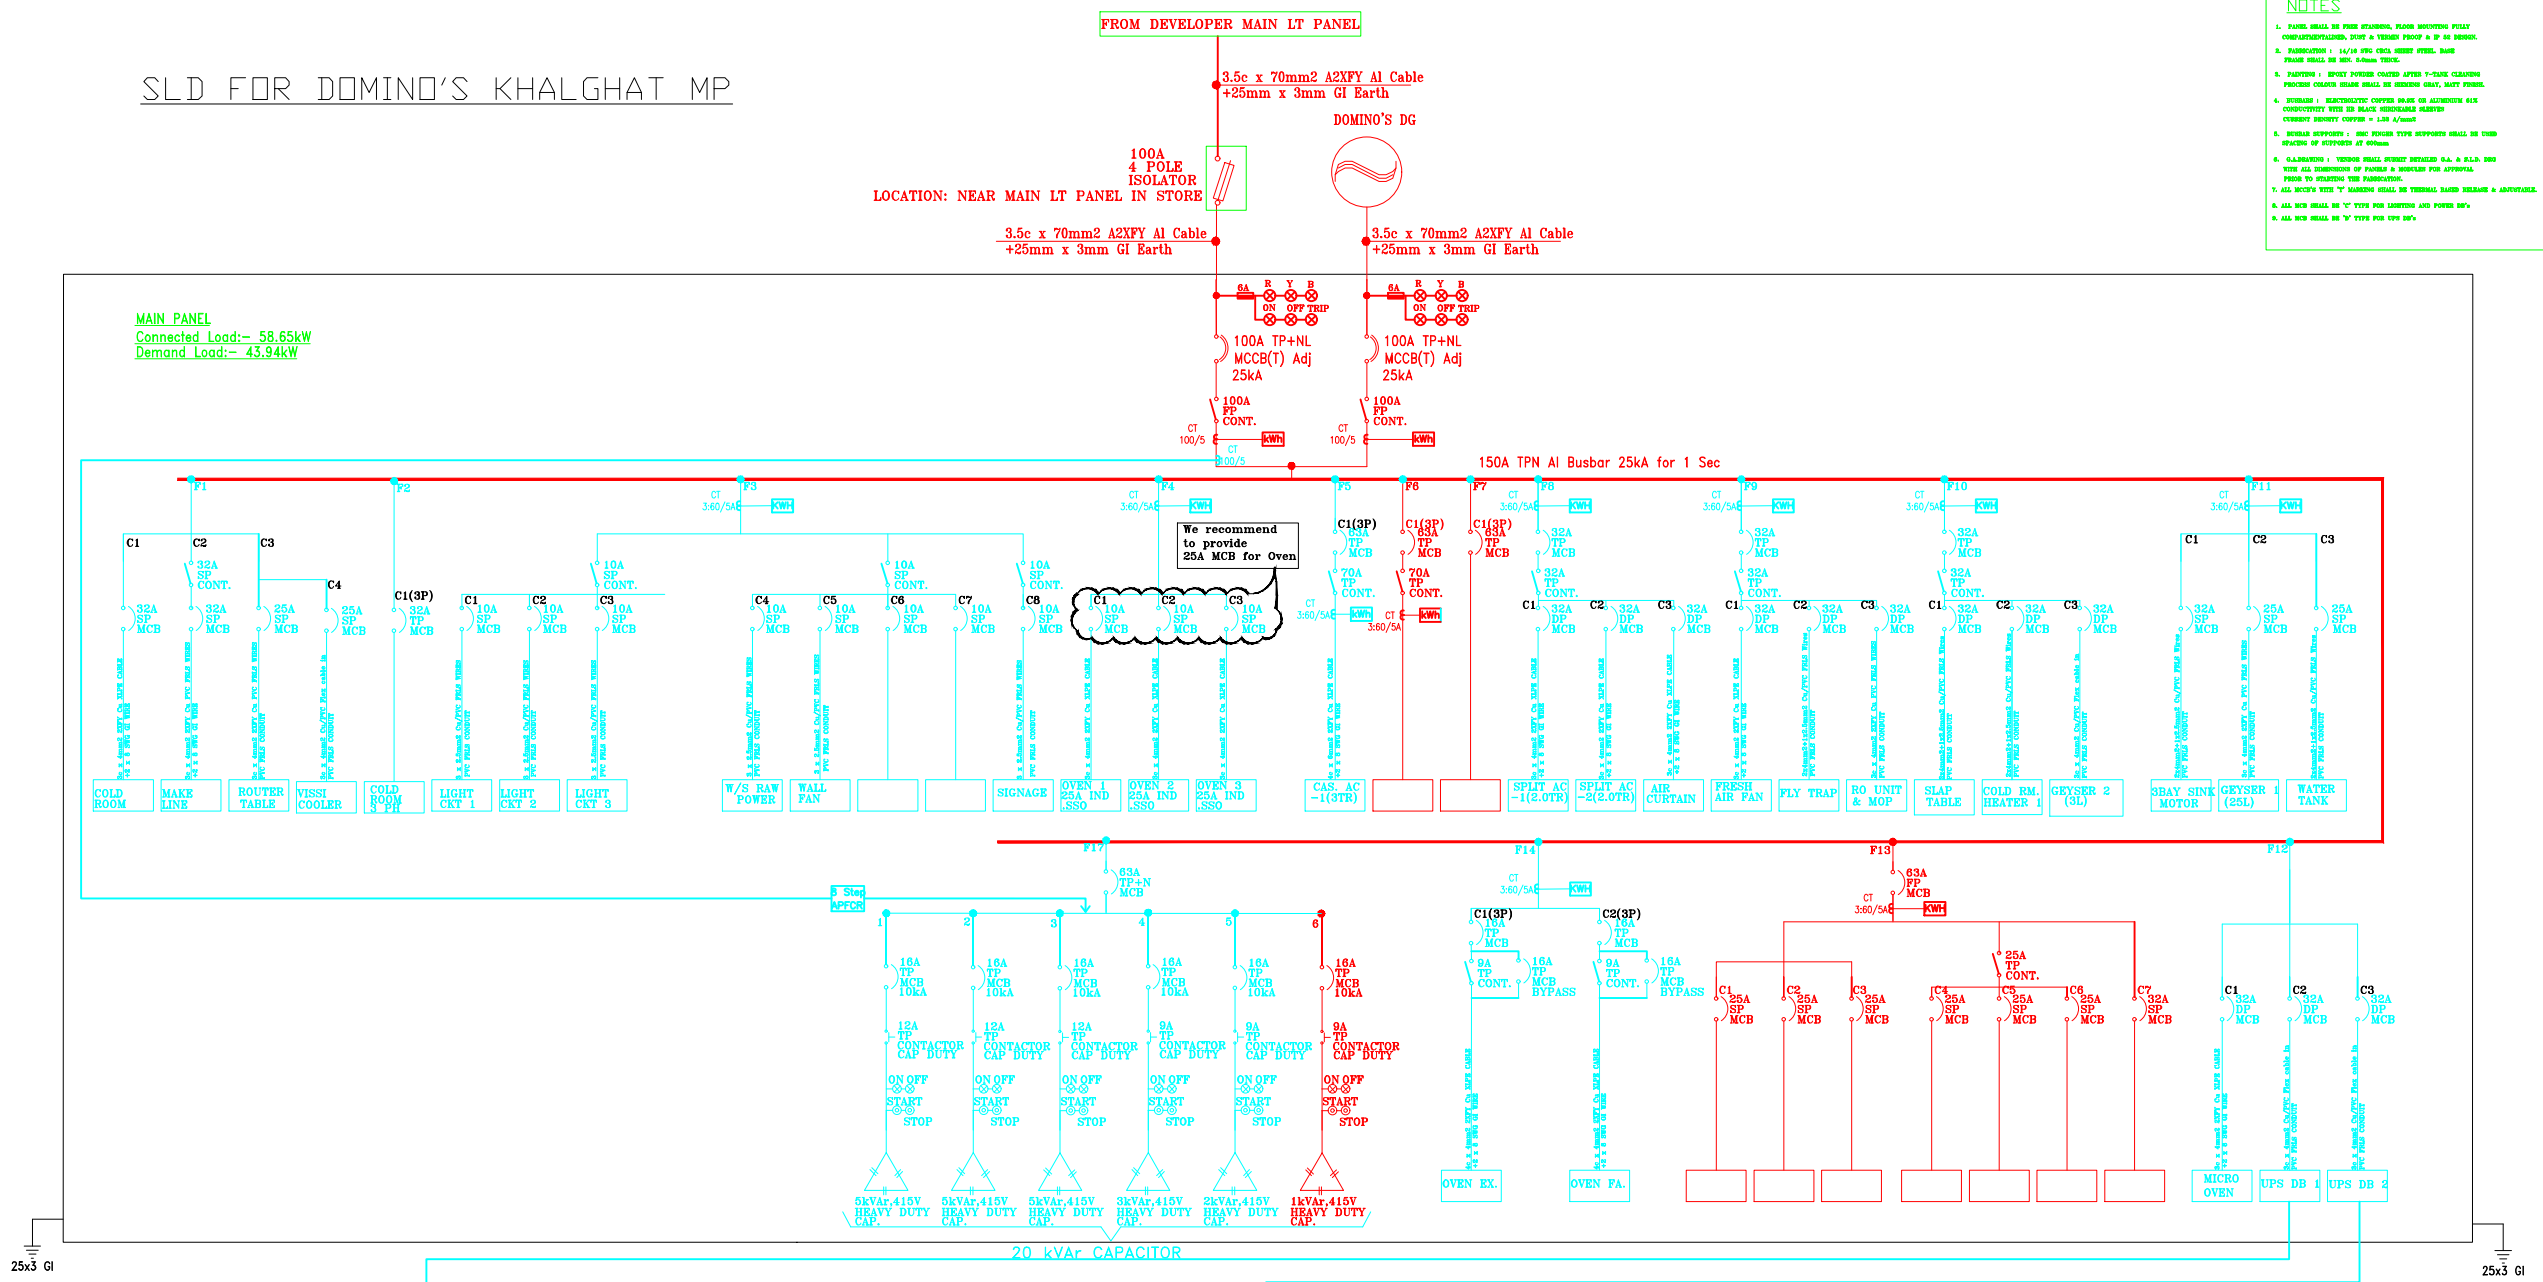

POWER AND LIGHTING WIRING DETAILS

POWER : 3 x 4.0 Cu/PVC WIRES or Flexible Cable IN PVC FRLS CONDUITS/IN CEILING/FLOORING.

LIGHTING : 3 x 2.5mm² Cu/PVC WIRES IN PVC FRLS CONDUITS IN CEILING.

UPS : 3 x 2.5mm² Cu/PVC Flex Cables

PROJECT DOMINOS KHALGHAT MP	ISSUED FOR TENDER	
	STUDIO² STUDIO SQUARE ARCHITECTURE INTERIOR DESIGN STORE PLANNING 2209, KALPITA ENCLAVE, B.N. ROAD, ANDHERI (E), MUMBAI 400 059 - TEL: +91 22 2682 8482	
ARCHITECTS STUDO SQUARE	TITLE SINGLE LINE DIAGRAM	
	DRN BY SHC	CHK BY ANH
SCALE N.T.S.	DWG.NO 142-22-120	DATE 04/03/2024