


LEGEND'S:

S.N.	DESCRIPTION	SYMBOL
01.	HYDRANT PIPE	
02.	GAS DETECTOR@600MM/PFL	
03.	GAS PANEL	
04.	FIRE PANEL	
05.	HEAT DETECTOR	
06.	SMOKE DETECTOR	
07.	FIRE EXTINGUISHER K TYPE-6KG	
08.	FIRE EXTINGUISHER CO2-5KG	
08.	FIRE EXTINGUISHER ABC-6KG	
10.	MANNUAL CALL POINT	
11.	HOOTER	

Bikanervala Fire Alarm System Layout

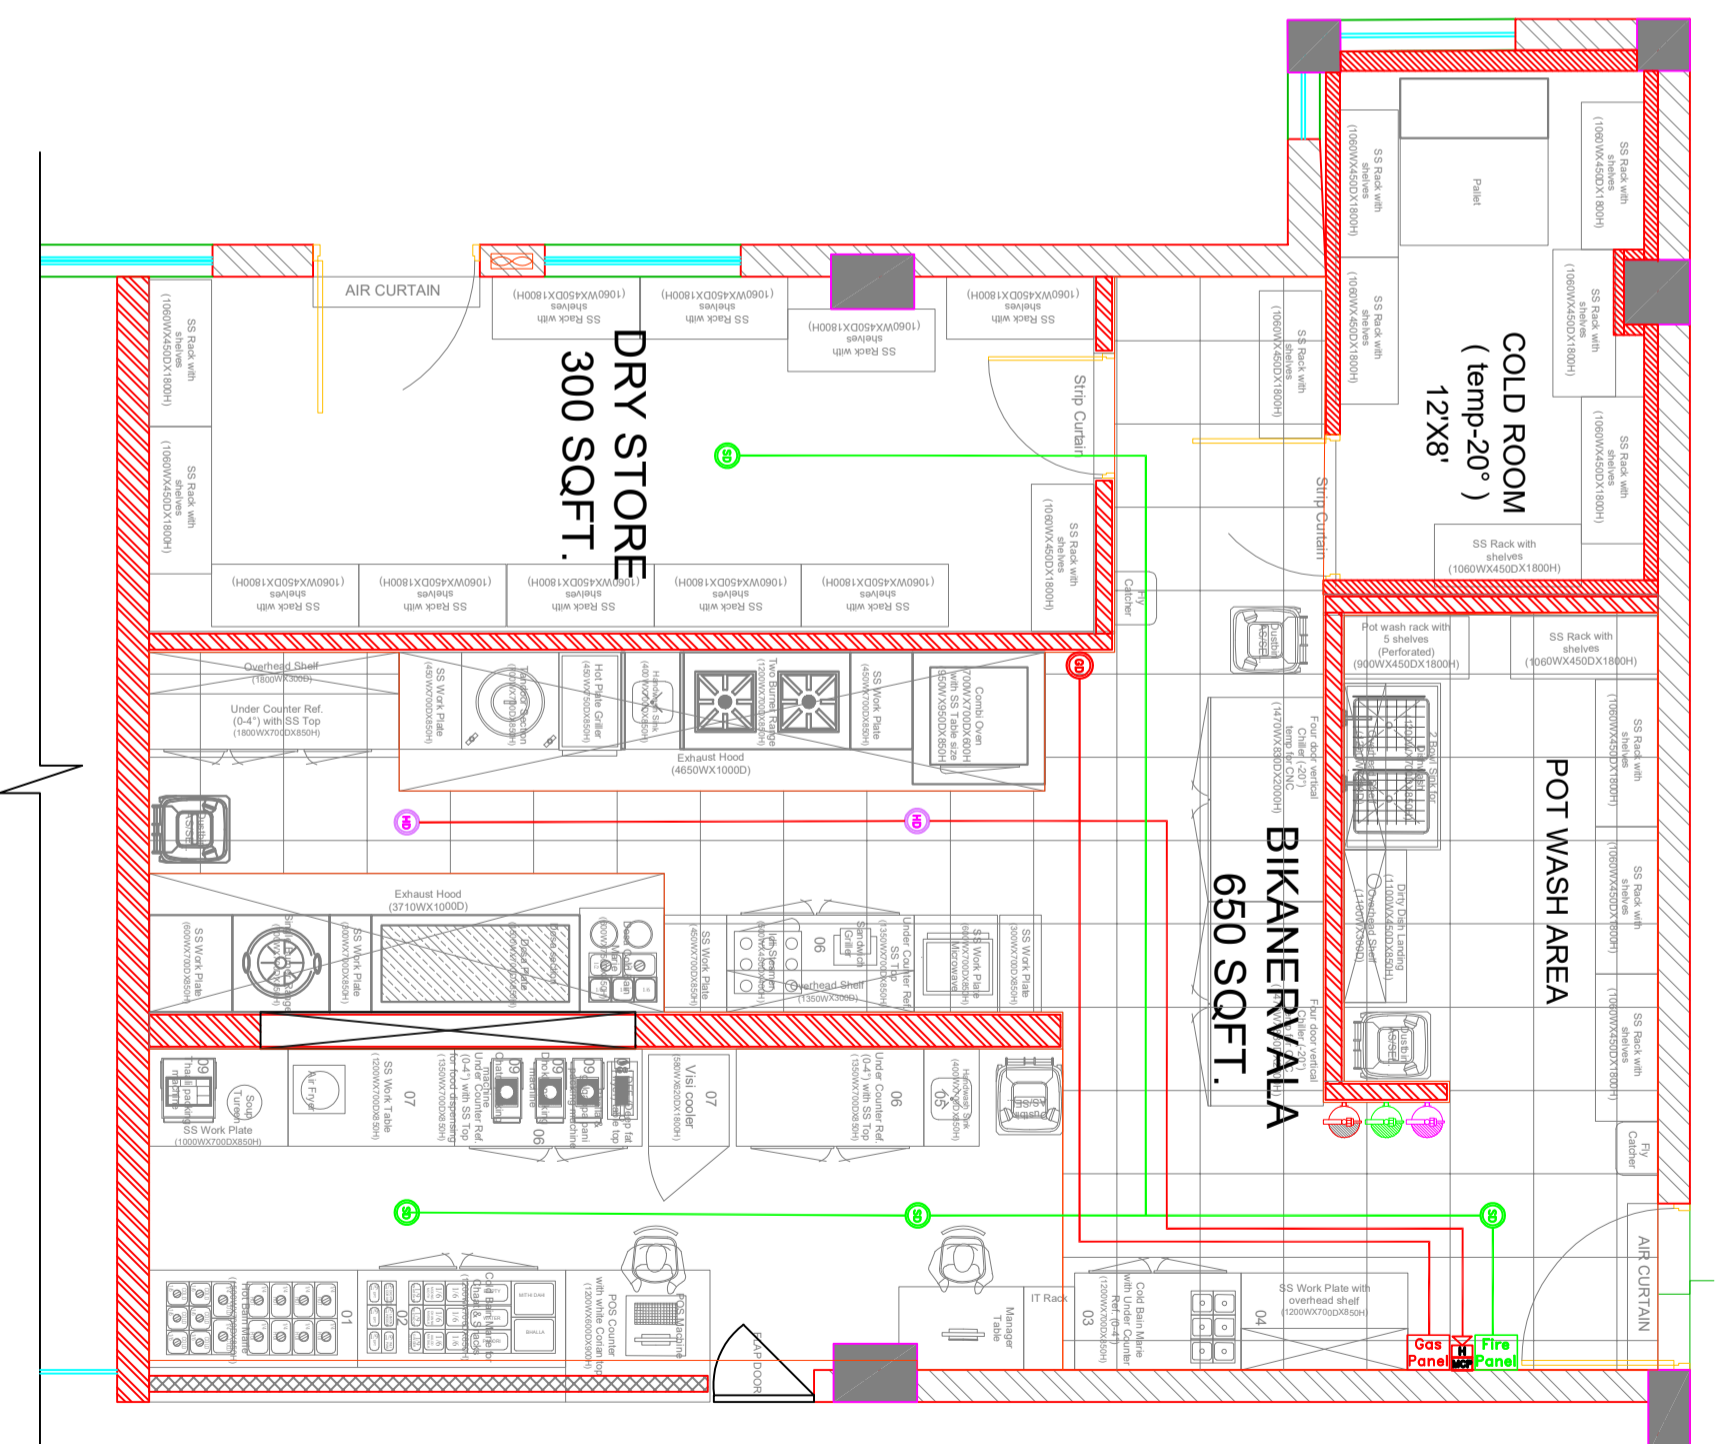

TRAVEL FOOD SERVICES

STATUS OF RELEASE:

FOR APPROVAL

FOR DISCUSSION

FOR TENDER

FOR CONSTRUCTION

STAMP:

DRAWING TITLE: BIKANERVALA@EKLERA FIRE ALARM SYSTEM LAYOUT

PROJECT NAME: CUBE STOP

CLIENT NAME:

ARCHITECT: TFS

DRAWING NO: BK-FAS-01-RO

DRAWING NO:

SCALE: NORTH

DATE: 25-04-2024

PREP: NIROU SHRIVALL

CHKD: DHEERAJ YADAV

APPVD: RITUPARN SHARMA

REV.	DATE	PREP BY	CHK BY	APPVD BY	REMARK