

Chai Point, Noida Airport



CHAI POINT

PROJECT

Chai Point
Noida Airport

GENERAL NOTES

ALL DIMENSIONS TO BE CHECKED ON SITE BY CONTRACTORS
DO NOT SCALE THE DRAWINGS
REPORT ANY DISCREPANCIES TO THE AUTHORS
ALL RIGHTS RESERVED BY THE AUTHOR

REVISION

Index of Sheets

Sheet	Title	Sheet	Title	Sheet	Title
A110	Cover Sheet	A119	Ceiling Layout	A128	Counter Elevation
A111	Design Intent	A120	Lighting Layout	A129	Counter Section
A112	Base Layout	A121	Finishes Layout	A130	Counter Section
A113	Material Palette	A122	CCTV & Speaker Layout		
A115	Equipment Layout	A123	Electrical Layout		
A117	Partition Layout	A124	Plumbing Layout		
A118	Flooring Layout	A125	Drain Layout		
		A126	Marking Plan		
		A127	Elevation		

DRAWING TITLE

Cover

DRAWING NUMB.

A 110

SCALE

DATE

23.09.2024

DESIGN STAGE

Concept Design

REVISION

R3

Chai Point
Design



CHAI POINT

PROJECT

Chai Point
Noida Airport

GENERAL NOTES

ALL DIMENSIONS TO BE CHECKED ON SITE BY CONTRACTORS
DO NOT SCALE THE DRAWINGS
REPORT ANY DISCREPANCIES TO THE AUTHORS
ALL RIGHTS RESERVED BY THE AUTHOR

REVISION

DRAWING TITLE

Design Intent

DRAWING NUMB.

A 111

SCALE

DATE

23.09.2024

DESIGN STAGE

Concept Design

REVISION

R3

Chai Point
Design



CHAI POINT

PROJECT

**Chai Point
Noida Airport**

GENERAL NOTES

ALL DIMENSIONS TO BE CHECKED ON SITE BY CONTRACTORS
DO NOT SCALE THE DRAWINGS
REPORT ANY DISCREPANCIES TO THE AUTHORS
ALL RIGHTS RESERVED BY THE AUTHOR

REVISION

DRAWING TITLE

Base Layout

DRAWING NUMB.

A 112

SCALE

DATE

23.09.2024


DESIGN STAGE

Concept Design

REVISION

R3

**Chai Point
Design**

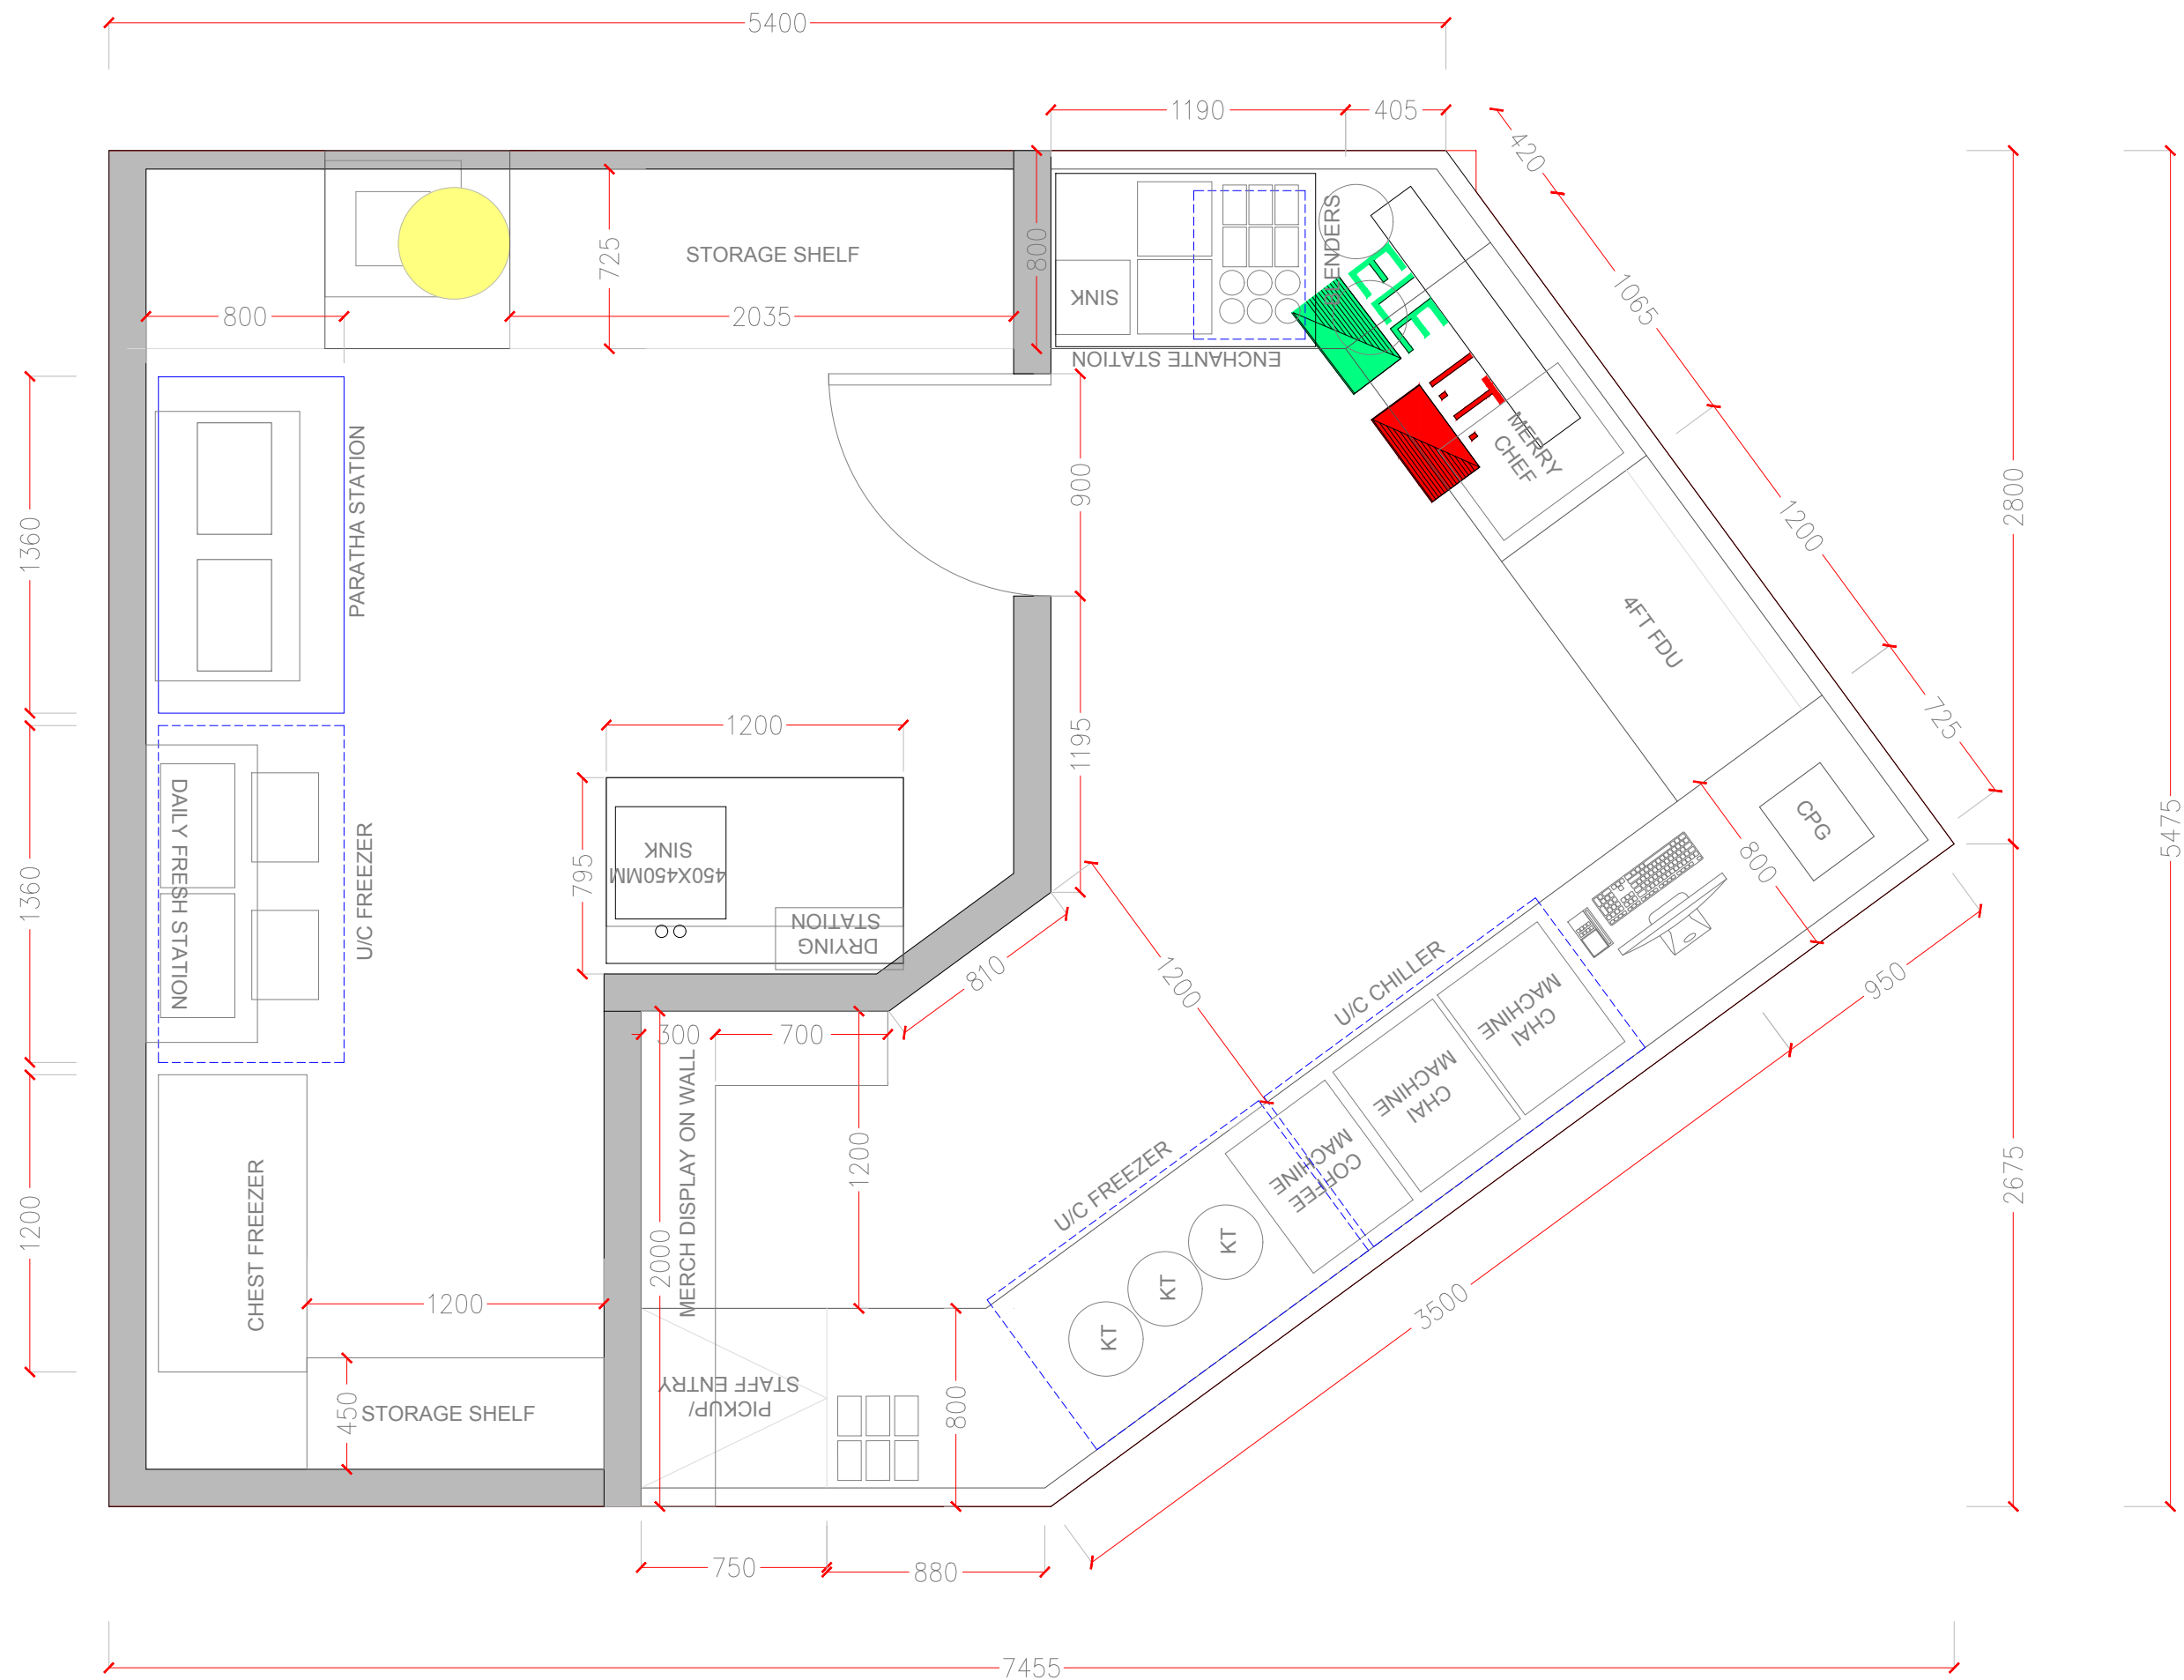



CHAI POINT

PROJECT

Chai Point
Noida Airport

GENERAL NOTES

ALL DIMENSIONS TO BE CHECKED ON SITE BY
CONTRACTORS
DO NOT SCALE THE DRAWINGS
REPORT ANY DISCREPANCIES TO THE AUTHORS
ALL RIGHTS RESERVED BY THE AUTHOR

REVISION

DRAWING TITLE

Material Palette

DRAWING NUMB.

A 113

SCALE

DATE

23.09.2024

DESIGN STAGE

Concept Design

REVISION

R3

Chai Point
Design



**300x75 WHITE
TILES
HERRINGBONE**



**STATUARIO QUARTZ
FOR COUNTER TOP**



**5375 SUD SATURNO
WALNUT - GREENLAM**



**7557 DEEP JUNGLE
ASIAN PAINTS**



 
**ASIAN PAINTS
PLATINUM DISC 8297**



**TEXTURE PAINT -
ASIAN PAINTS
ALMOST IVORY L156**




**RUBBER WOOD
FINISHED IN
MELAMINE POLISH**



**GREENLAM
WHITE 101**



**JOHNSON
300x200 WHITE TILE**

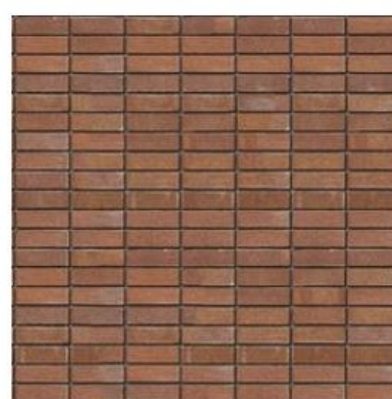

**TERRACOTTA
BRICK TILE
CLADDING**



**GREENLAM
DARK GREY 261**



CHAI POINT

PROJECT

Chai Point
Noida Airport

GENERAL NOTES

ALL DIMENSIONS TO BE CHECKED ON SITE BY CONTRACTORS
DO NOT SCALE THE DRAWINGS
REPORT ANY DISCREPANCIES TO THE AUTHORS
ALL RIGHTS RESERVED BY THE AUTHOR

REVISION

DRAWING TITLE

Equipment Layout

DRAWING NUMB.

A 115

SCALE

DATE

23.09.2024

DESIGN STAGE

Concept Design

REVISION

R3


Chai Point
Design

SS TABLES

DESCRIPTION	CODE
SINK & DRYING STATION WITH SS SHUTTERS - SPACE FOR DUSTBIN AND GREASE TRAP BELOW. WITH HOLES CUT OF FOR MIXERS 1200X750X850MM (1NOS) SINK - 450X450MM	I-SS 01.0
UNDER COUNTER FREEZER 1350X750X850MM (1NOS)	I-SS 03.0
UNDER COUNTER CHILLERS 1350X750X850MM (1NOS)	I-SS 04.0
SS TABLE FOR WORK TABLE 750X600X900MM (1NOS)	I-SS 05.0
SS TABLE FOR WORK TABLE 750X1360X900MM (1NOS)	I-SS 06.0
CHEST FREEZER (1NOS)	I-SS 07.0

EQUIPMENTS

DESCRIPTION	CODE
HOT & COLD MIXERS ON SS TABLE (2NOS)	I-EQ 01.0
IKEA SHELF WITH HOLDERS (1NOS)	I-EQ 02.0
ICE CUBE MACHINE 30KG (1NOS)	I-EQ 03.0
MAGNETIC STAND FOR KIFE / SPOON (1NOS) IKEA	I-EQ 04.0
GN PANS 160X95MM (12 NOS)	I-EQ 05.0
JTC BLENDERS (2NOS)	I-EQ 06.0
PARATHA GRIDDLES 1VEG & 1NON-VEG	I-EQ 07.0
POS MACHINE (1NOS)	I-EQ 08.0
COFFEE MACHINE SINGLE(1NOS)	I-EQ 09.0
FILTER COFFEE 5L (1NOS)	I-EQ 10.0
SANDWICH GRILLER (2NOS)	I-EQ 11.0
MICROWAVE (2NOS)	I-EQ 12.0
CHAI KETTLES (3NOS)	I-EQ 13.0
CHAI MACHINE (2NOS)	I-EQ 14.0
FDU 4FT (1NOS)	I-EQ 15.0
BILLING MACHINE (1NOS)	I-EQ 16.0
EXHAUST HOOD HELLICA	I-EQ 17.0
RO UNIT (1NOS)	I-EQ 18.0
GEYSER UNIT (1NOS)	I-EQ 19.0
GREASE TRAP (1NOS)	I-EQ 20.0
MERRY CHEF (1NOS)	I-EQ 21.0
SS STORAGE SHELF (3NOS)	I-EQ 22.0

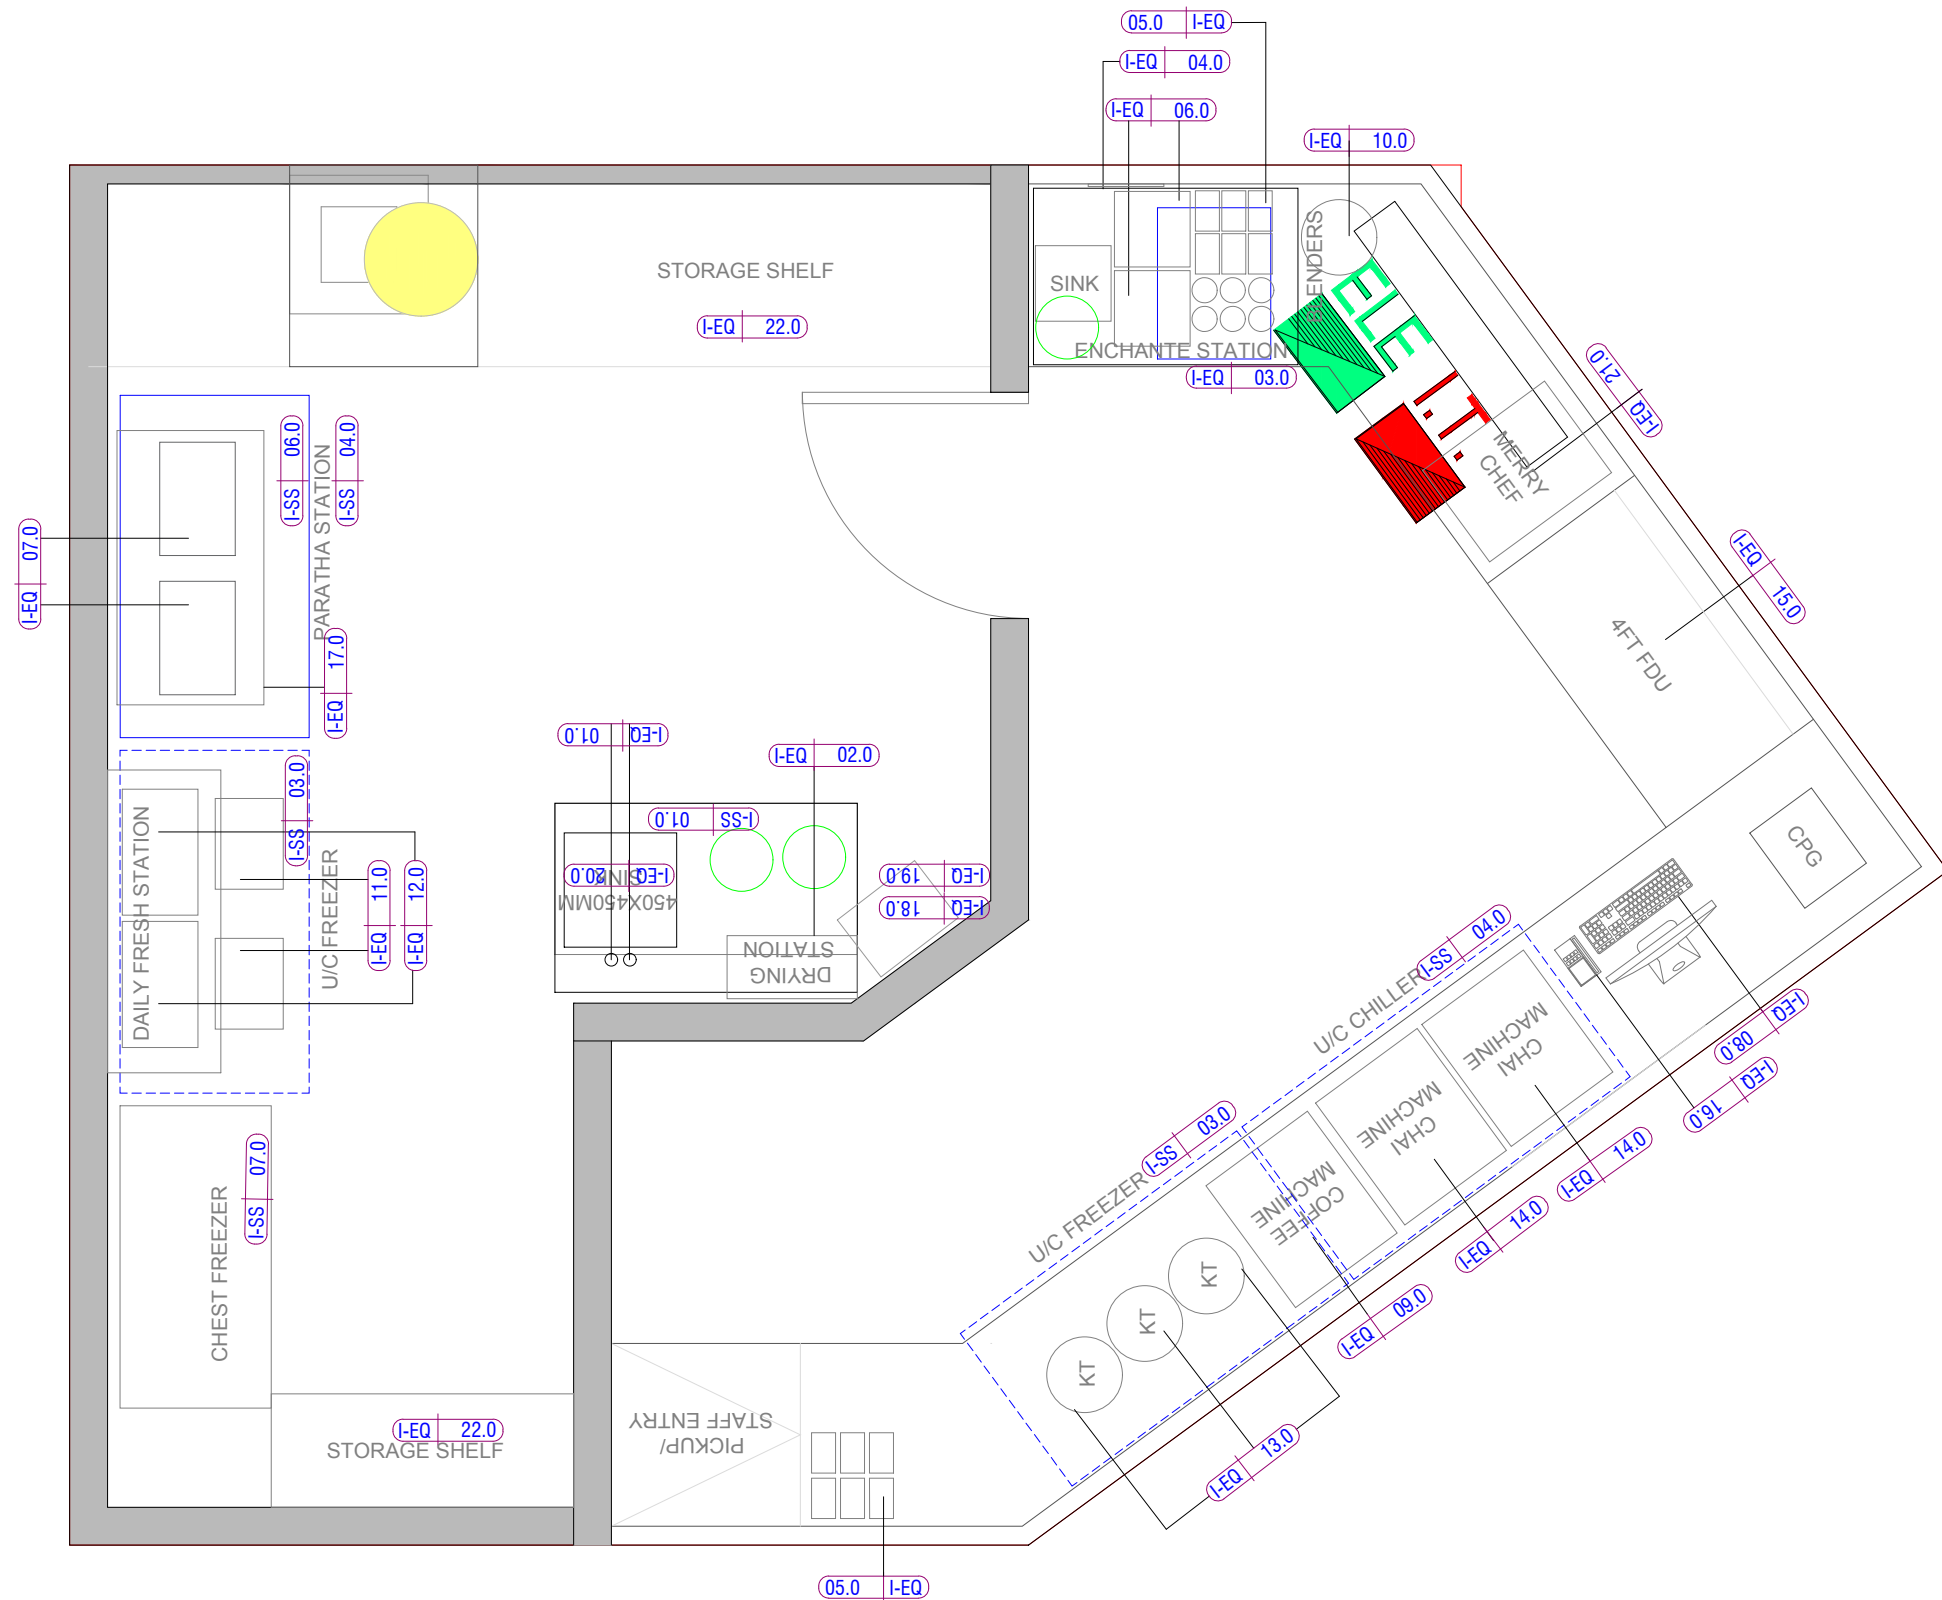



CHAI POINT

PROJECT

Chai Point
Noida Airport

GENERAL NOTES

ALL DIMENSIONS TO BE CHECKED ON SITE BY CONTRACTORS
DO NOT SCALE THE DRAWINGS
REPORT ANY DISCREPANCIES TO THE AUTHORS
ALL RIGHTS RESERVED BY THE AUTHOR

REVISION

DRAWING TITLE

Partition Layout

DRAWING NUMB.

A 117

SCALE

DATE

23.09.2024


DESIGN STAGE

Concept Design

REVISION

R3

Chai Point
Design

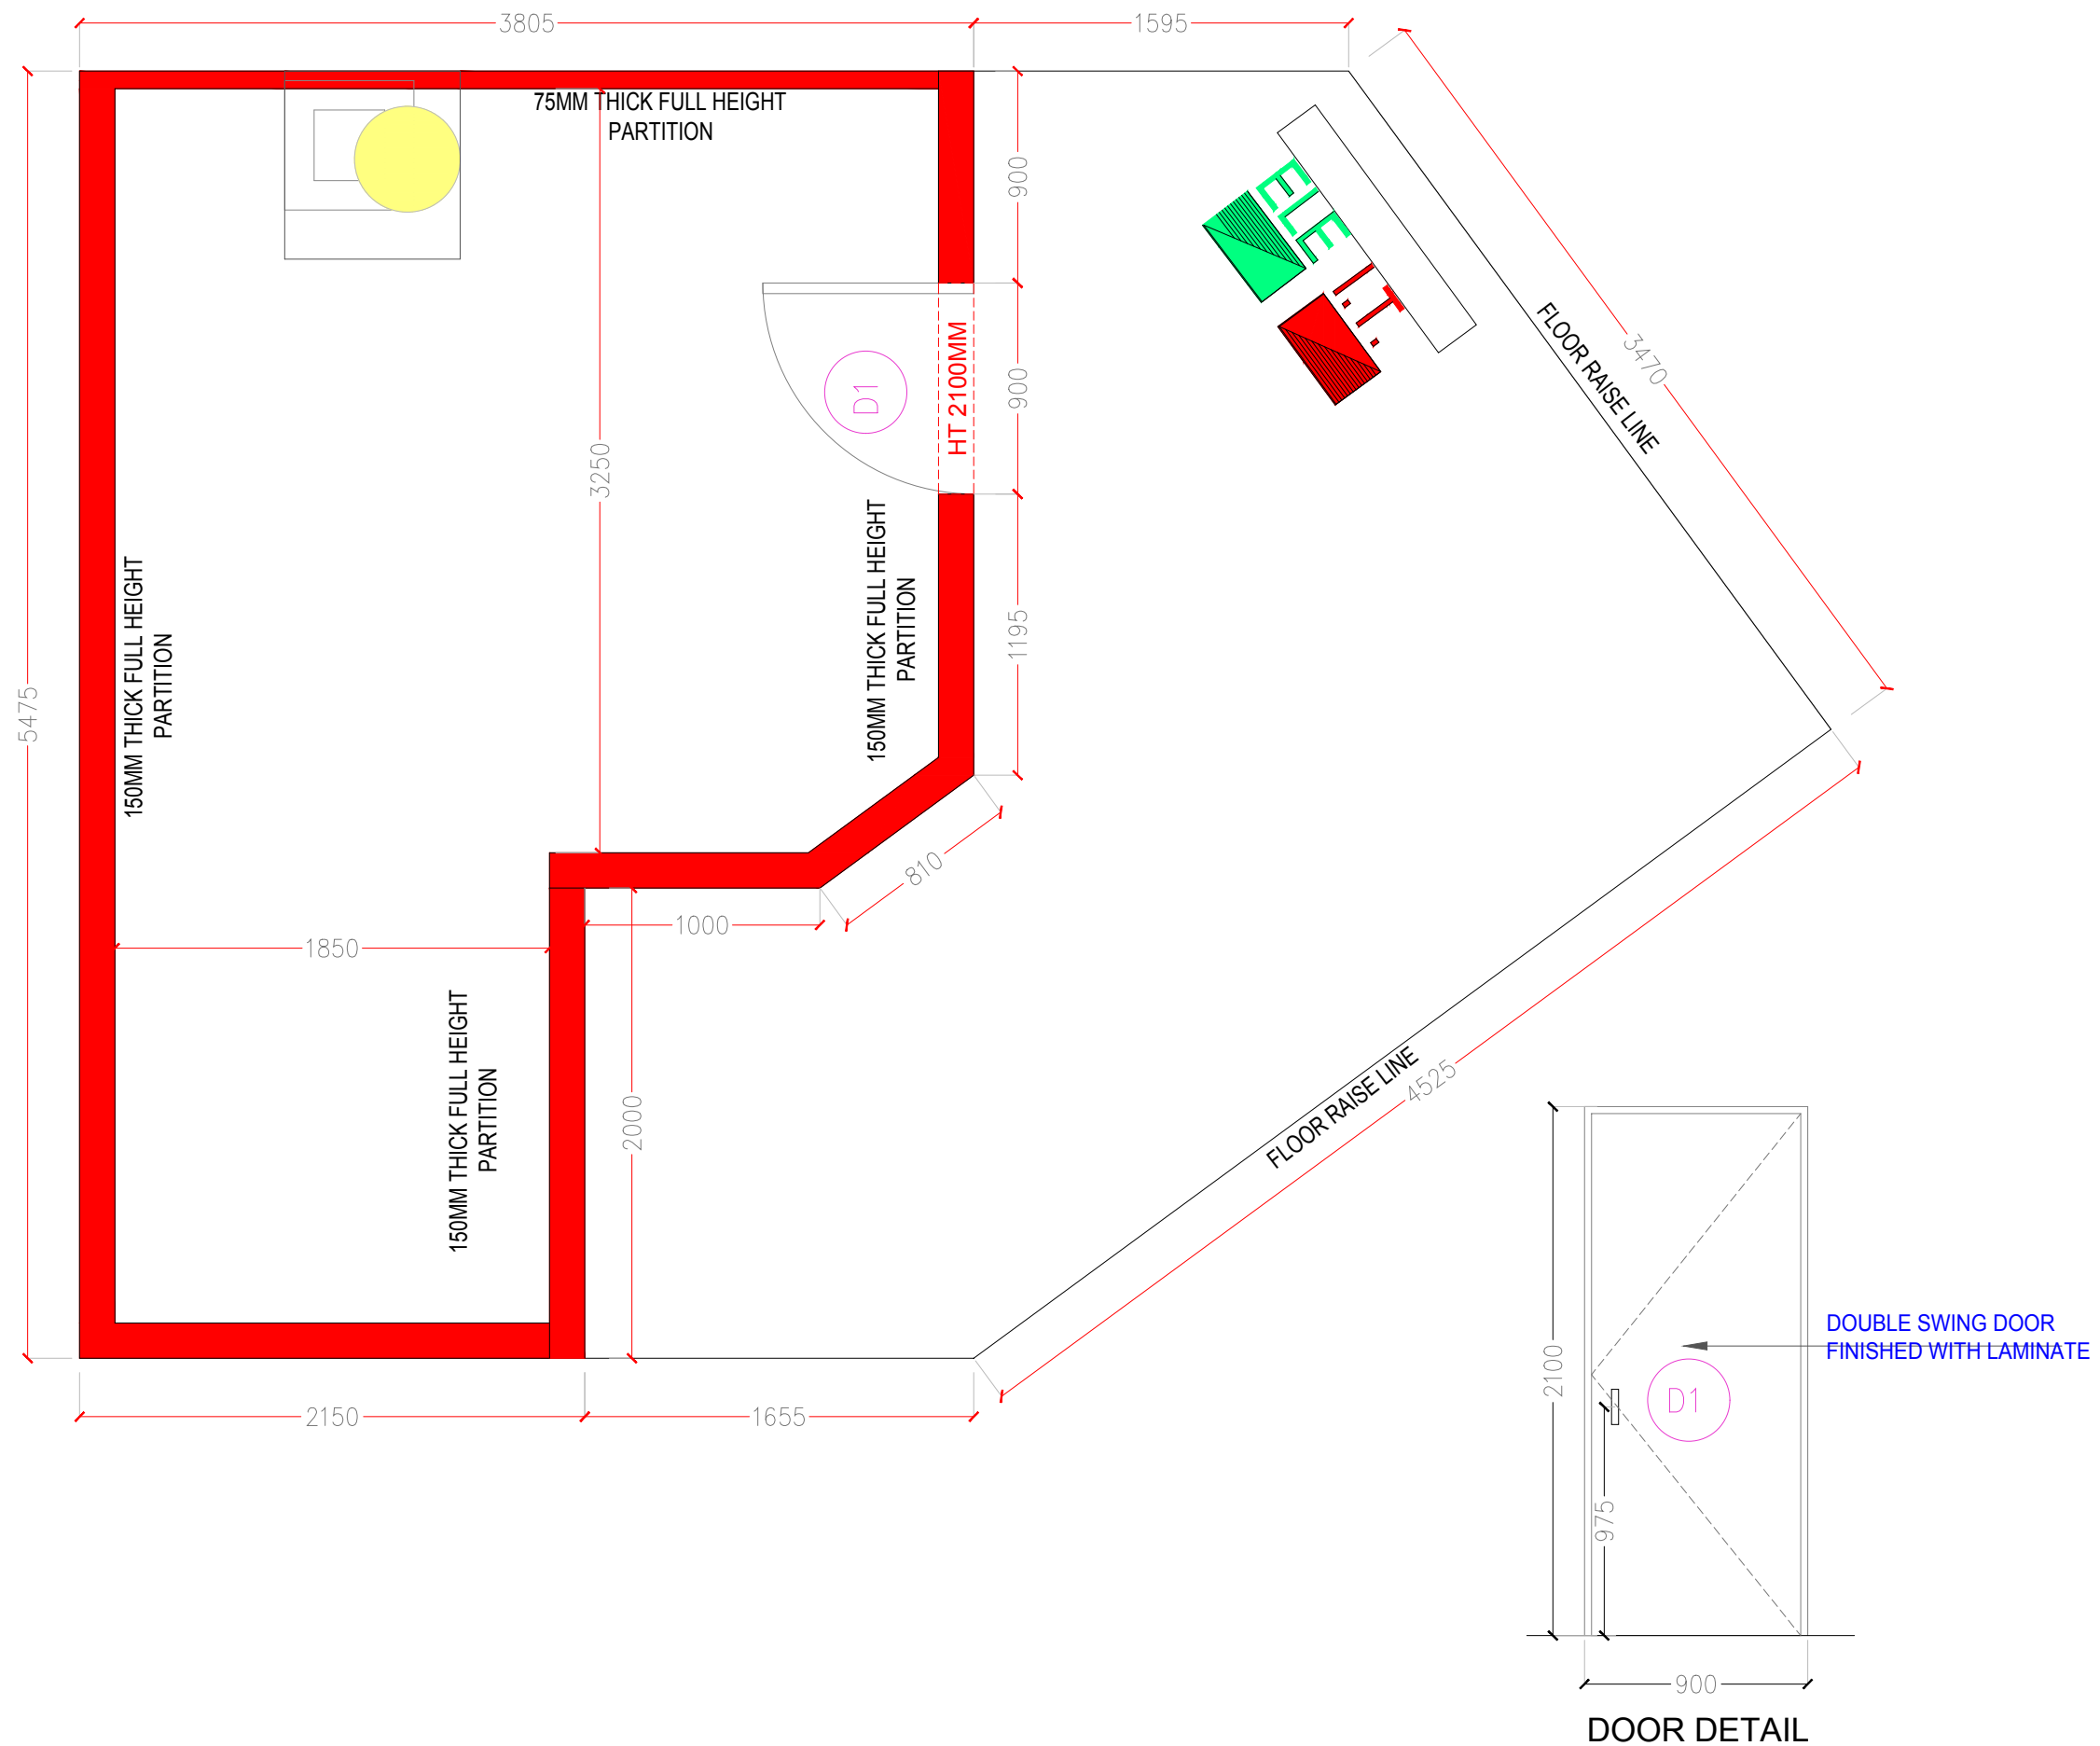



CHAI POINT


PROJECT

Chai Point
Noida Airport

GENERAL NOTES


ALL DIMENSIONS TO BE CHECKED ON SITE BY CONTRACTORS
DO NOT SCALE THE DRAWINGS
REPORT ANY DISCREPANCIES TO THE AUTHORS
ALL RIGHTS RESERVED BY THE AUTHOR

REVISION

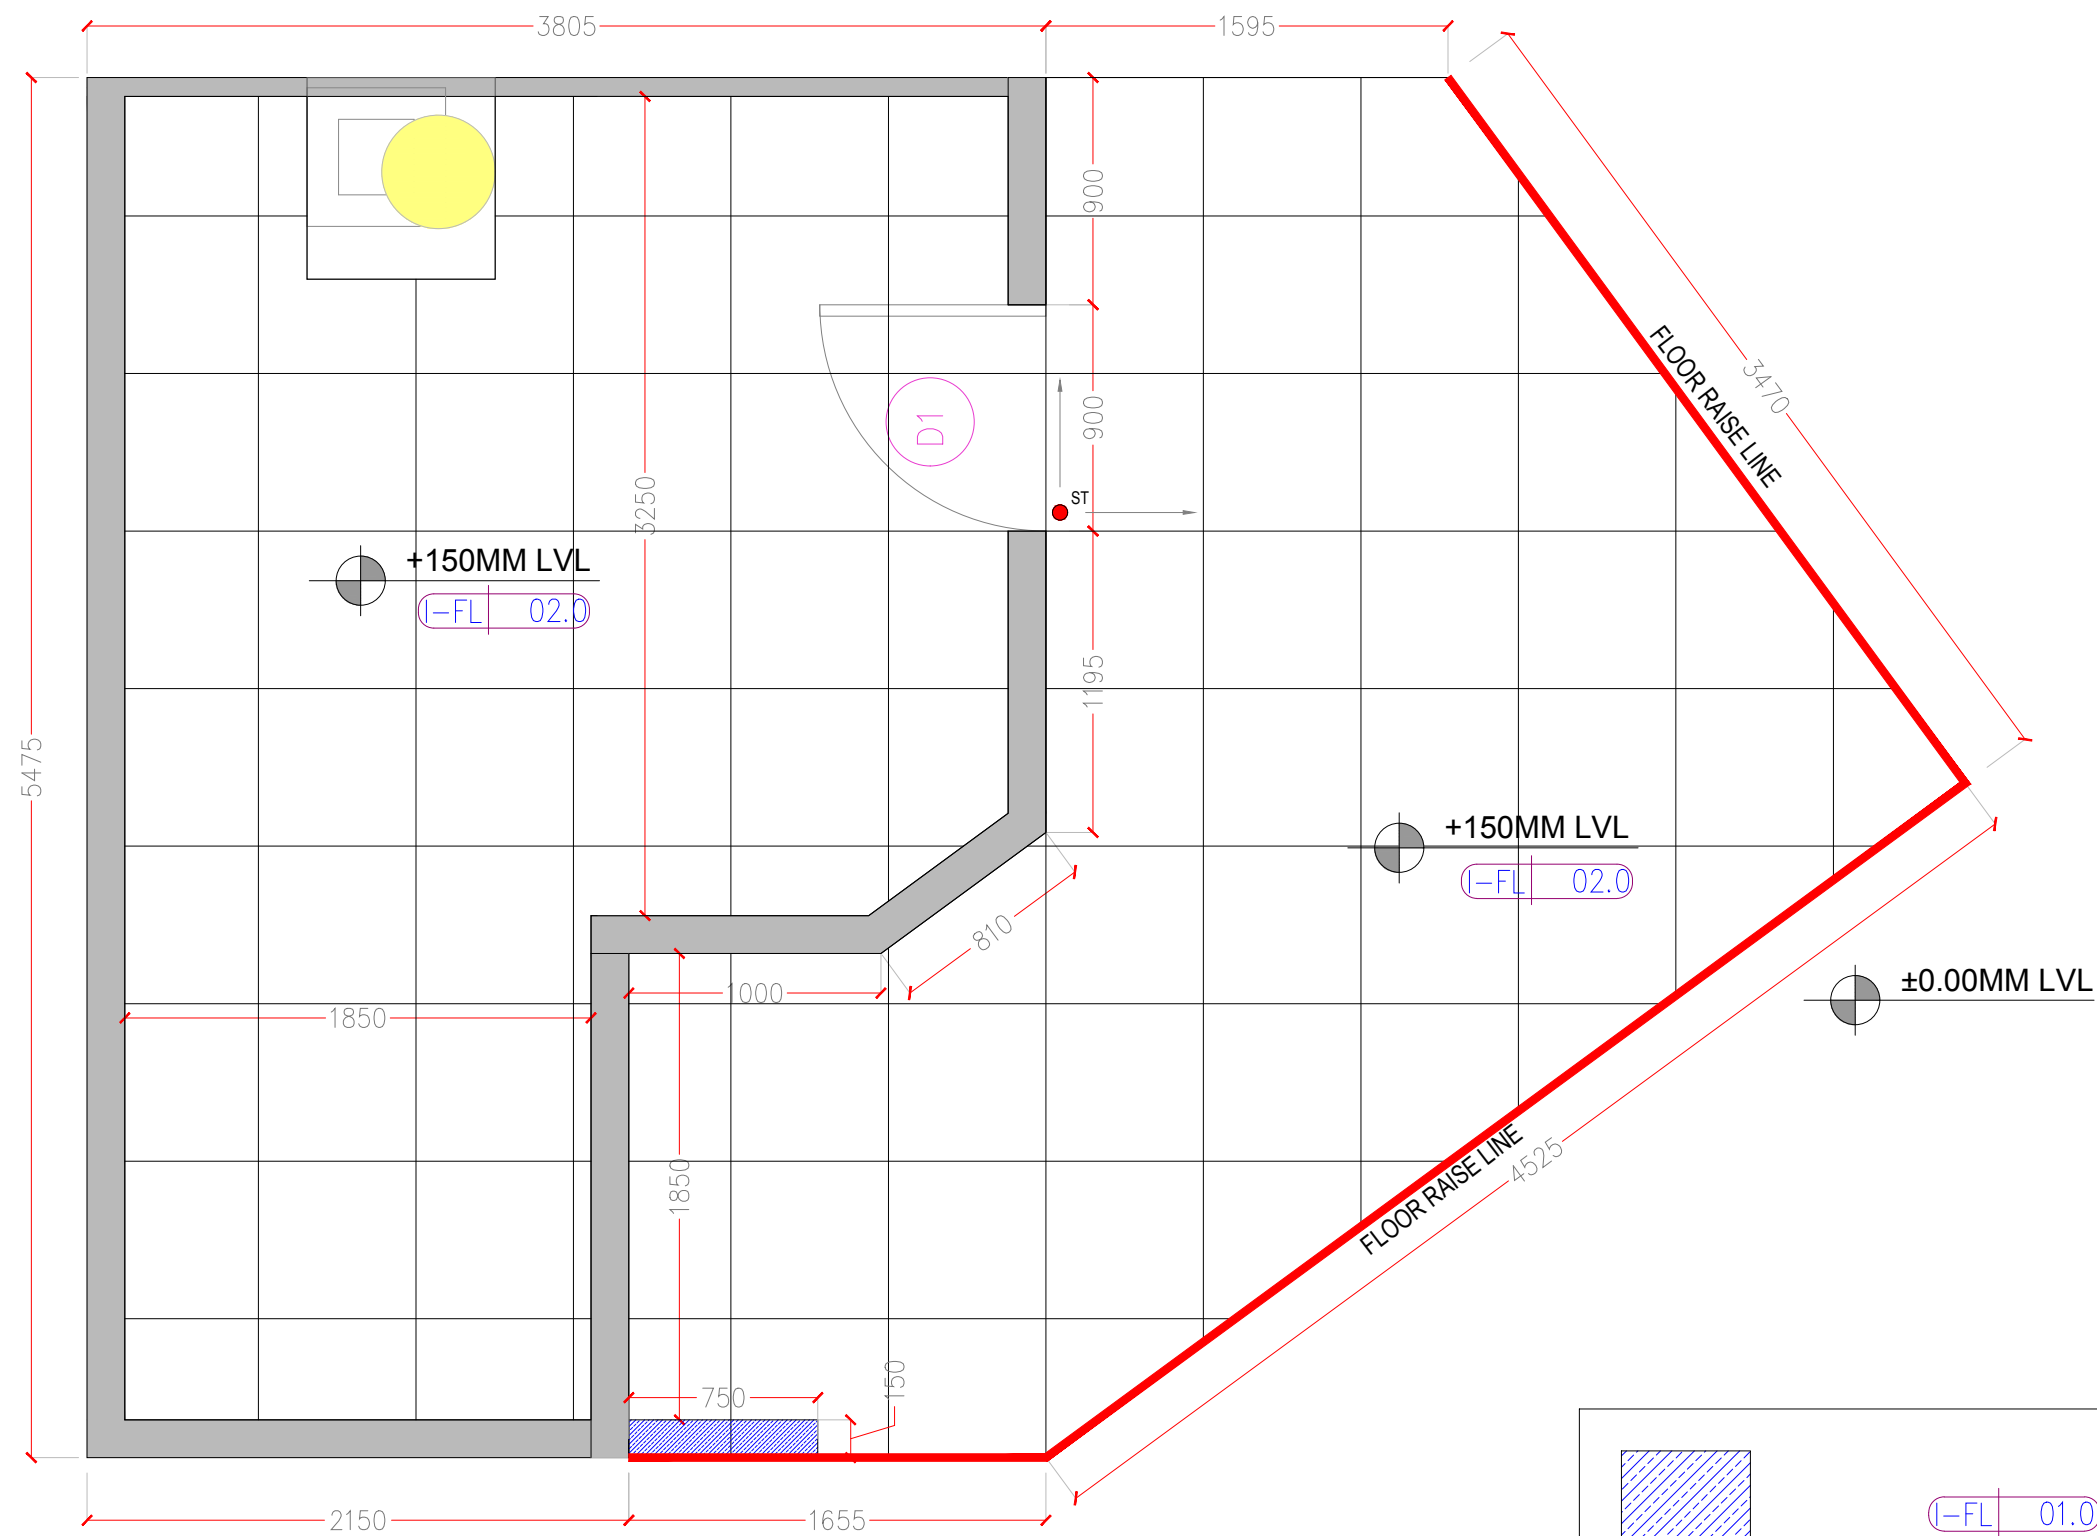

(-FL 01.0)

JET BLACK GRANITE

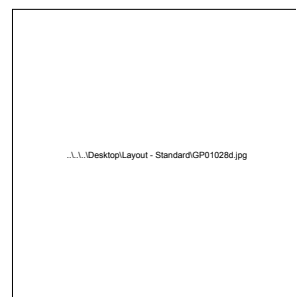



(-FL 02.0)

CEMENTO GRIS KAJARIA TILES




(-FL 04.0)

BLACK TILE SKIRTING

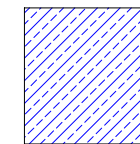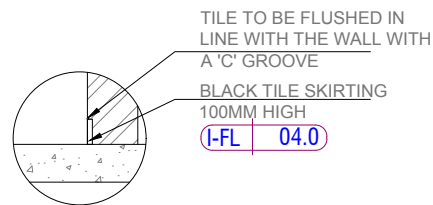

(-FL 01.0)
GRANITE STRIP

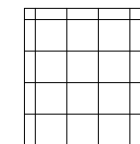

(-FL 02.0)
KITCHEN FLOORING



(-FL 04.0)
BLACK TILE SKIRTING

DRAWING TITLE

Flooring Layout

DRAWING NUMB.

A 118

SCALE

DATE

23.09.2024

DESIGN STAGE

Concept Design

REVISION

R3

Chai Point
Design



CHAI POINT


PROJECT

Chai Point
Noida Airport

GENERAL NOTES

ALL DIMENSIONS TO BE CHECKED ON SITE BY CONTRACTORS
DO NOT SCALE THE DRAWINGS
REPORT ANY DISCREPANCIES TO THE AUTHORS
ALL RIGHTS RESERVED BY THE AUTHOR

REVISION

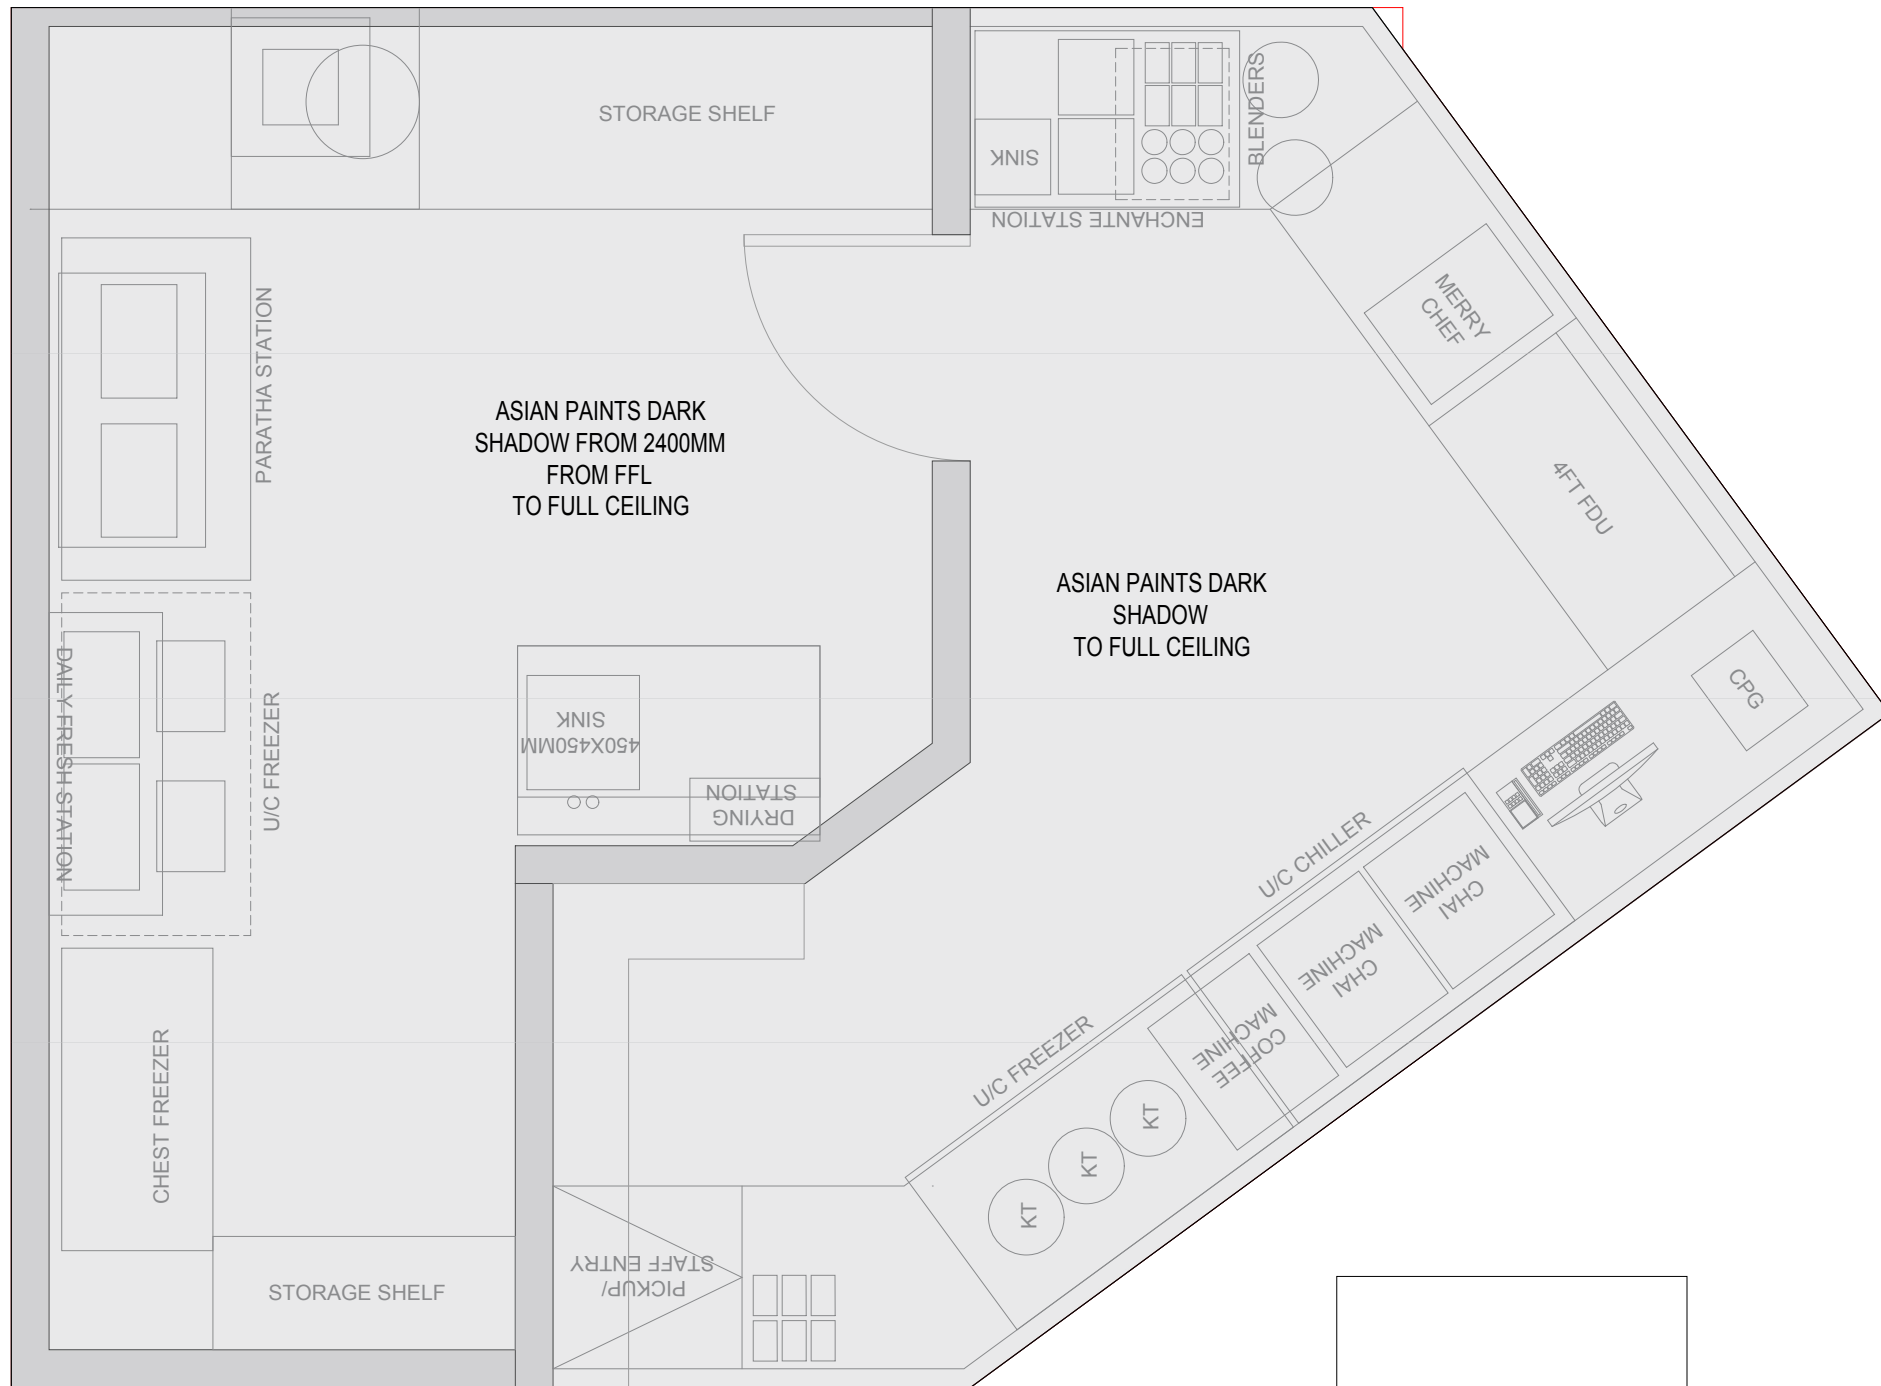

I-P | 03.0

**ASIAN PAINTS
DARK SHADOW
8294**

DRAWING TITLE

Ceiling finish Layout

DRAWING NUMB.

A 119

SCALE

DATE

23.09.2024

DESIGN STAGE

Concept Design

REVISION

R3

Chai Point
Design



CHAI POINT


PROJECT

Chai Point
Noida Airport

GENERAL NOTES

ALL DIMENSIONS TO BE CHECKED ON SITE BY CONTRACTORS
DO NOT SCALE THE DRAWINGS
REPORT ANY DISCREPANCIES TO THE AUTHORS
ALL RIGHTS RESERVED BY THE AUTHOR

REVISION

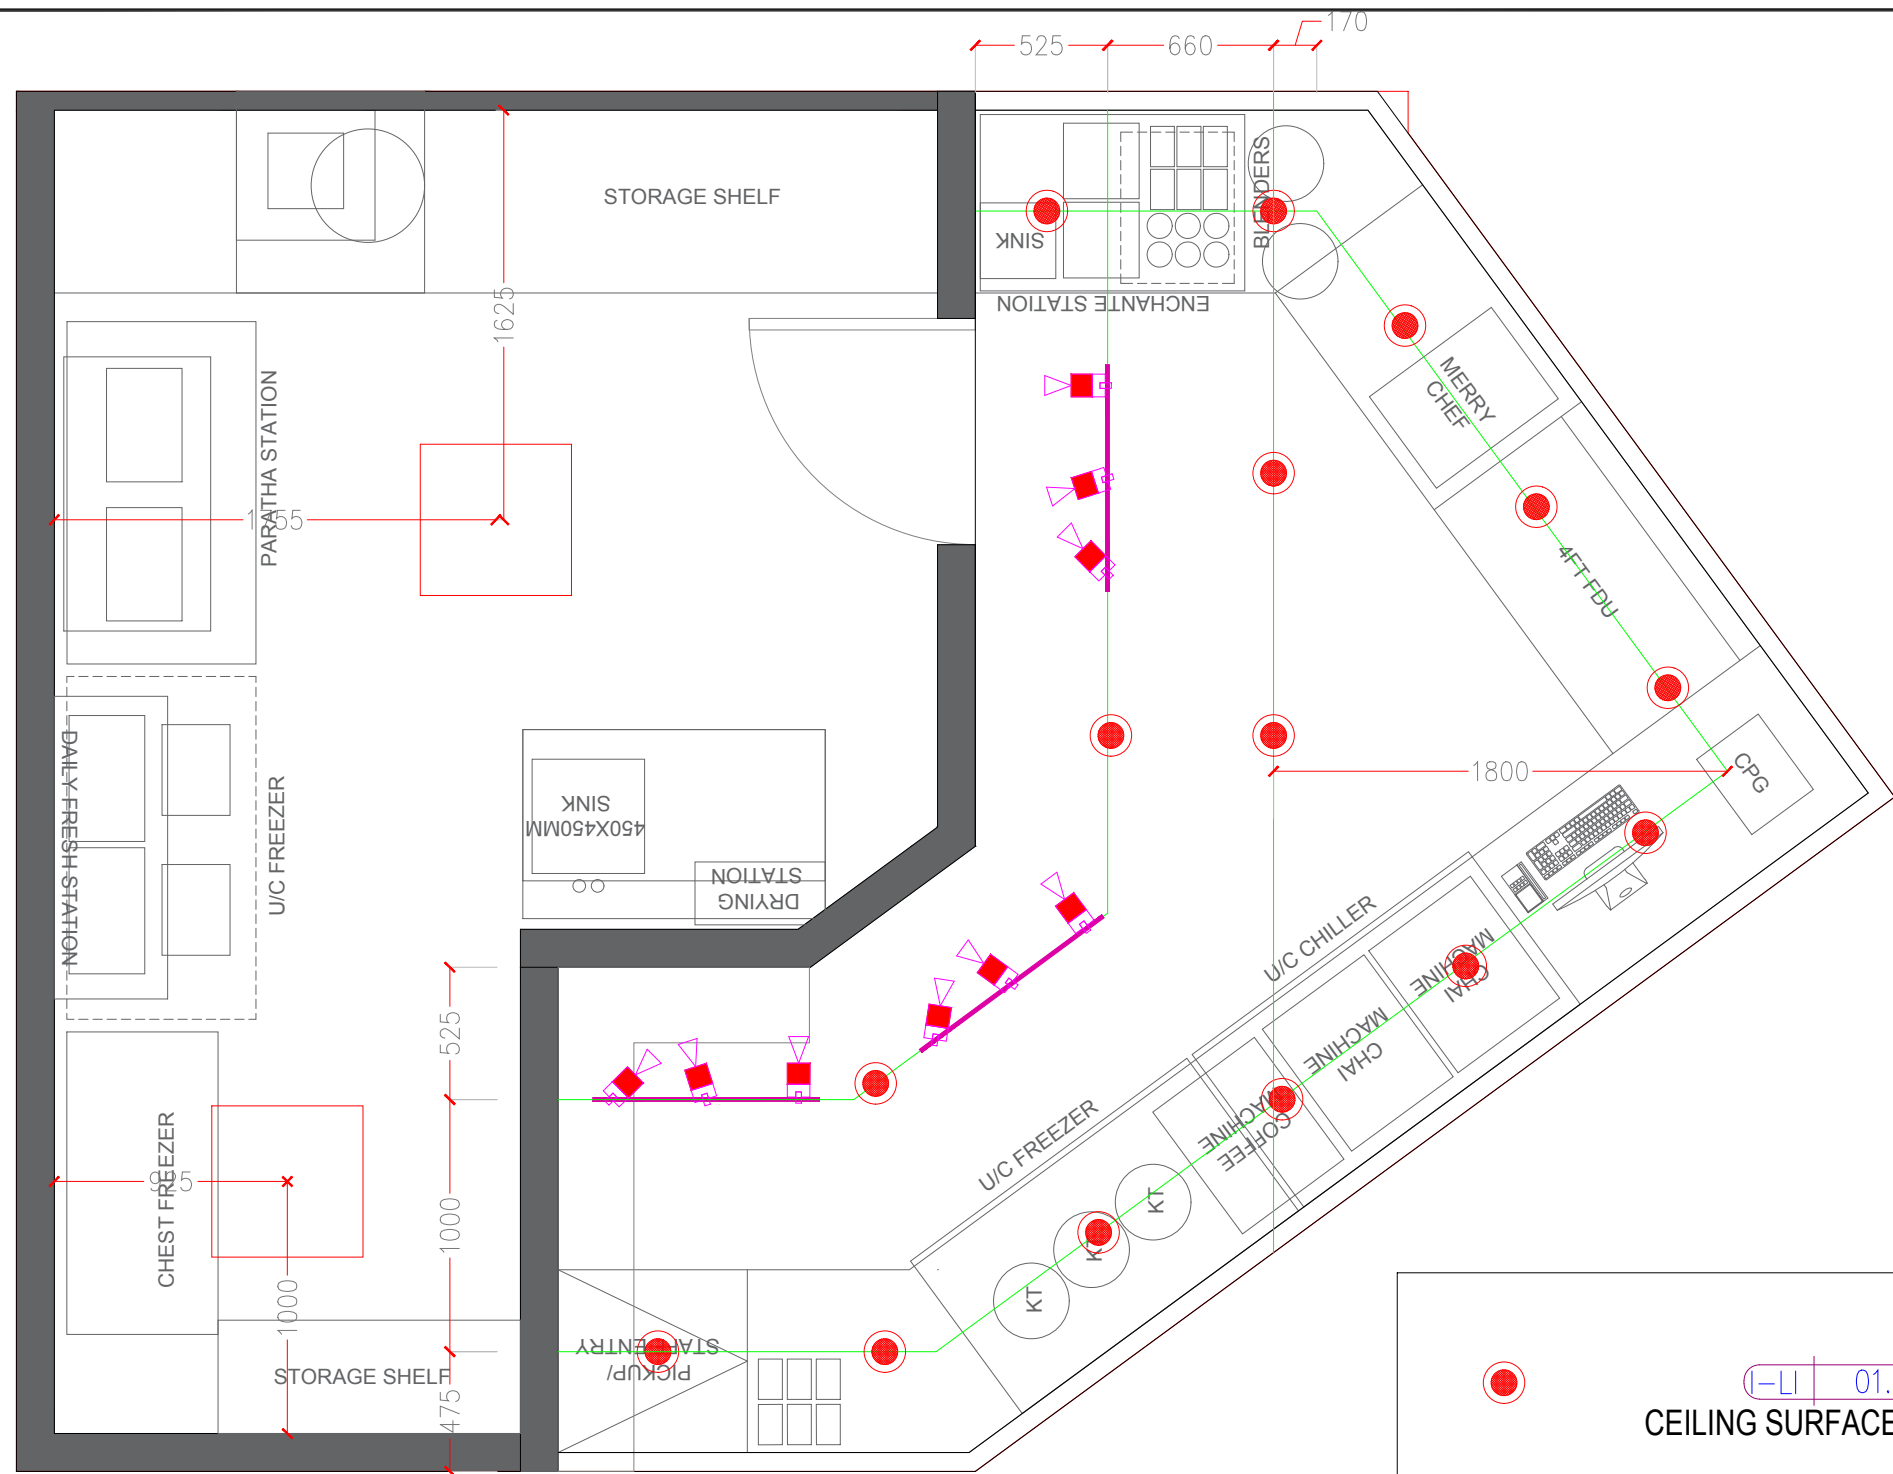


(I-LI | 01.0)
CEILING MOUNTED
SURFACE LIGHTS
15 NOS



(I-LI | 02.0)
TRACK LIGHTS
3 TRACKS 9 LIGHTS



(I-LI | 03.0)
2X2 PANLE LIGHTS
2 NOS

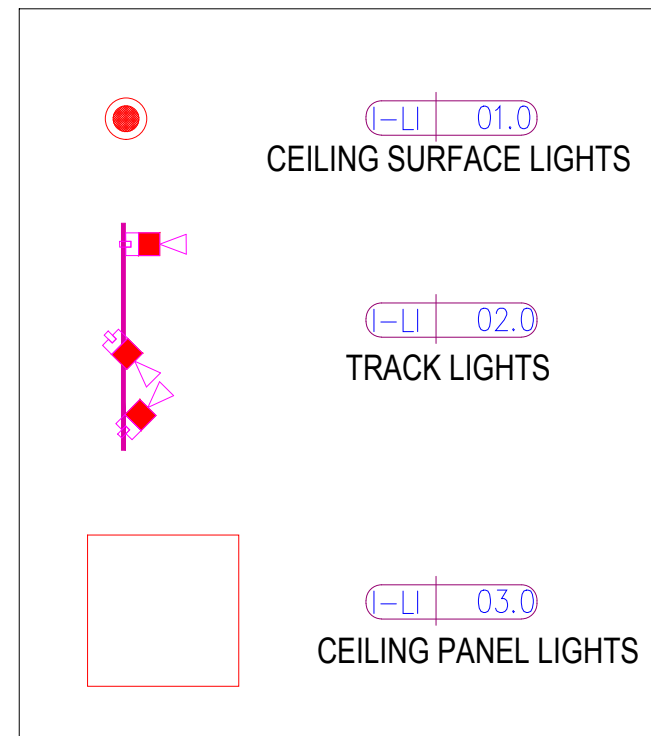

DRAWING TITLE

Lighting Layout

DRAWING NUMB.

A 120

SCALE

DATE

23.09.2024

DESIGN STAGE

Concept Design

REVISION

R3

Chai Point
Design



CHAI POINT

PROJECT

Chai Point
Noida Airport

GENERAL NOTES

ALL DIMENSIONS TO BE CHECKED ON SITE BY CONTRACTORS
DO NOT SCALE THE DRAWINGS
REPORT ANY DISCREPANCIES TO THE AUTHORS
ALL RIGHTS RESERVED BY THE AUTHOR

REVISION

DRAWING TITLE

Finishes Layout

DRAWING NUMB.

A 121

SCALE

DATE

23.09.2024


DESIGN STAGE

Concept Design

REVISION

R3

Chai Point
Design

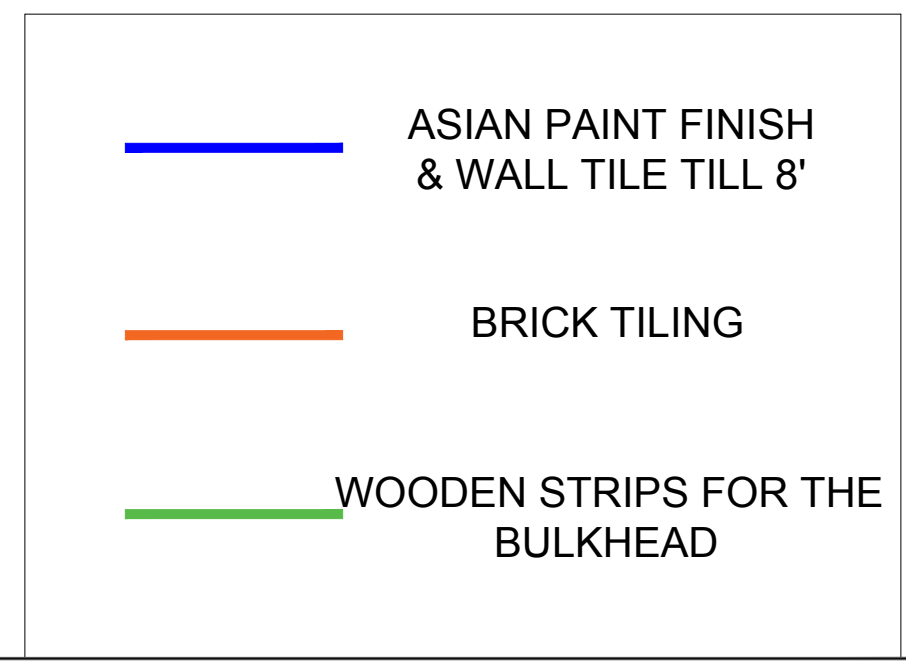



CHAI POINT


PROJECT

Chai Point
Noida Airport

GENERAL NOTES

ALL DIMENSIONS TO BE CHECKED ON SITE BY CONTRACTORS
DO NOT SCALE THE DRAWINGS
REPORT ANY DISCREPANCIES TO THE AUTHORS
ALL RIGHTS RESERVED BY THE AUTHOR

REVISION

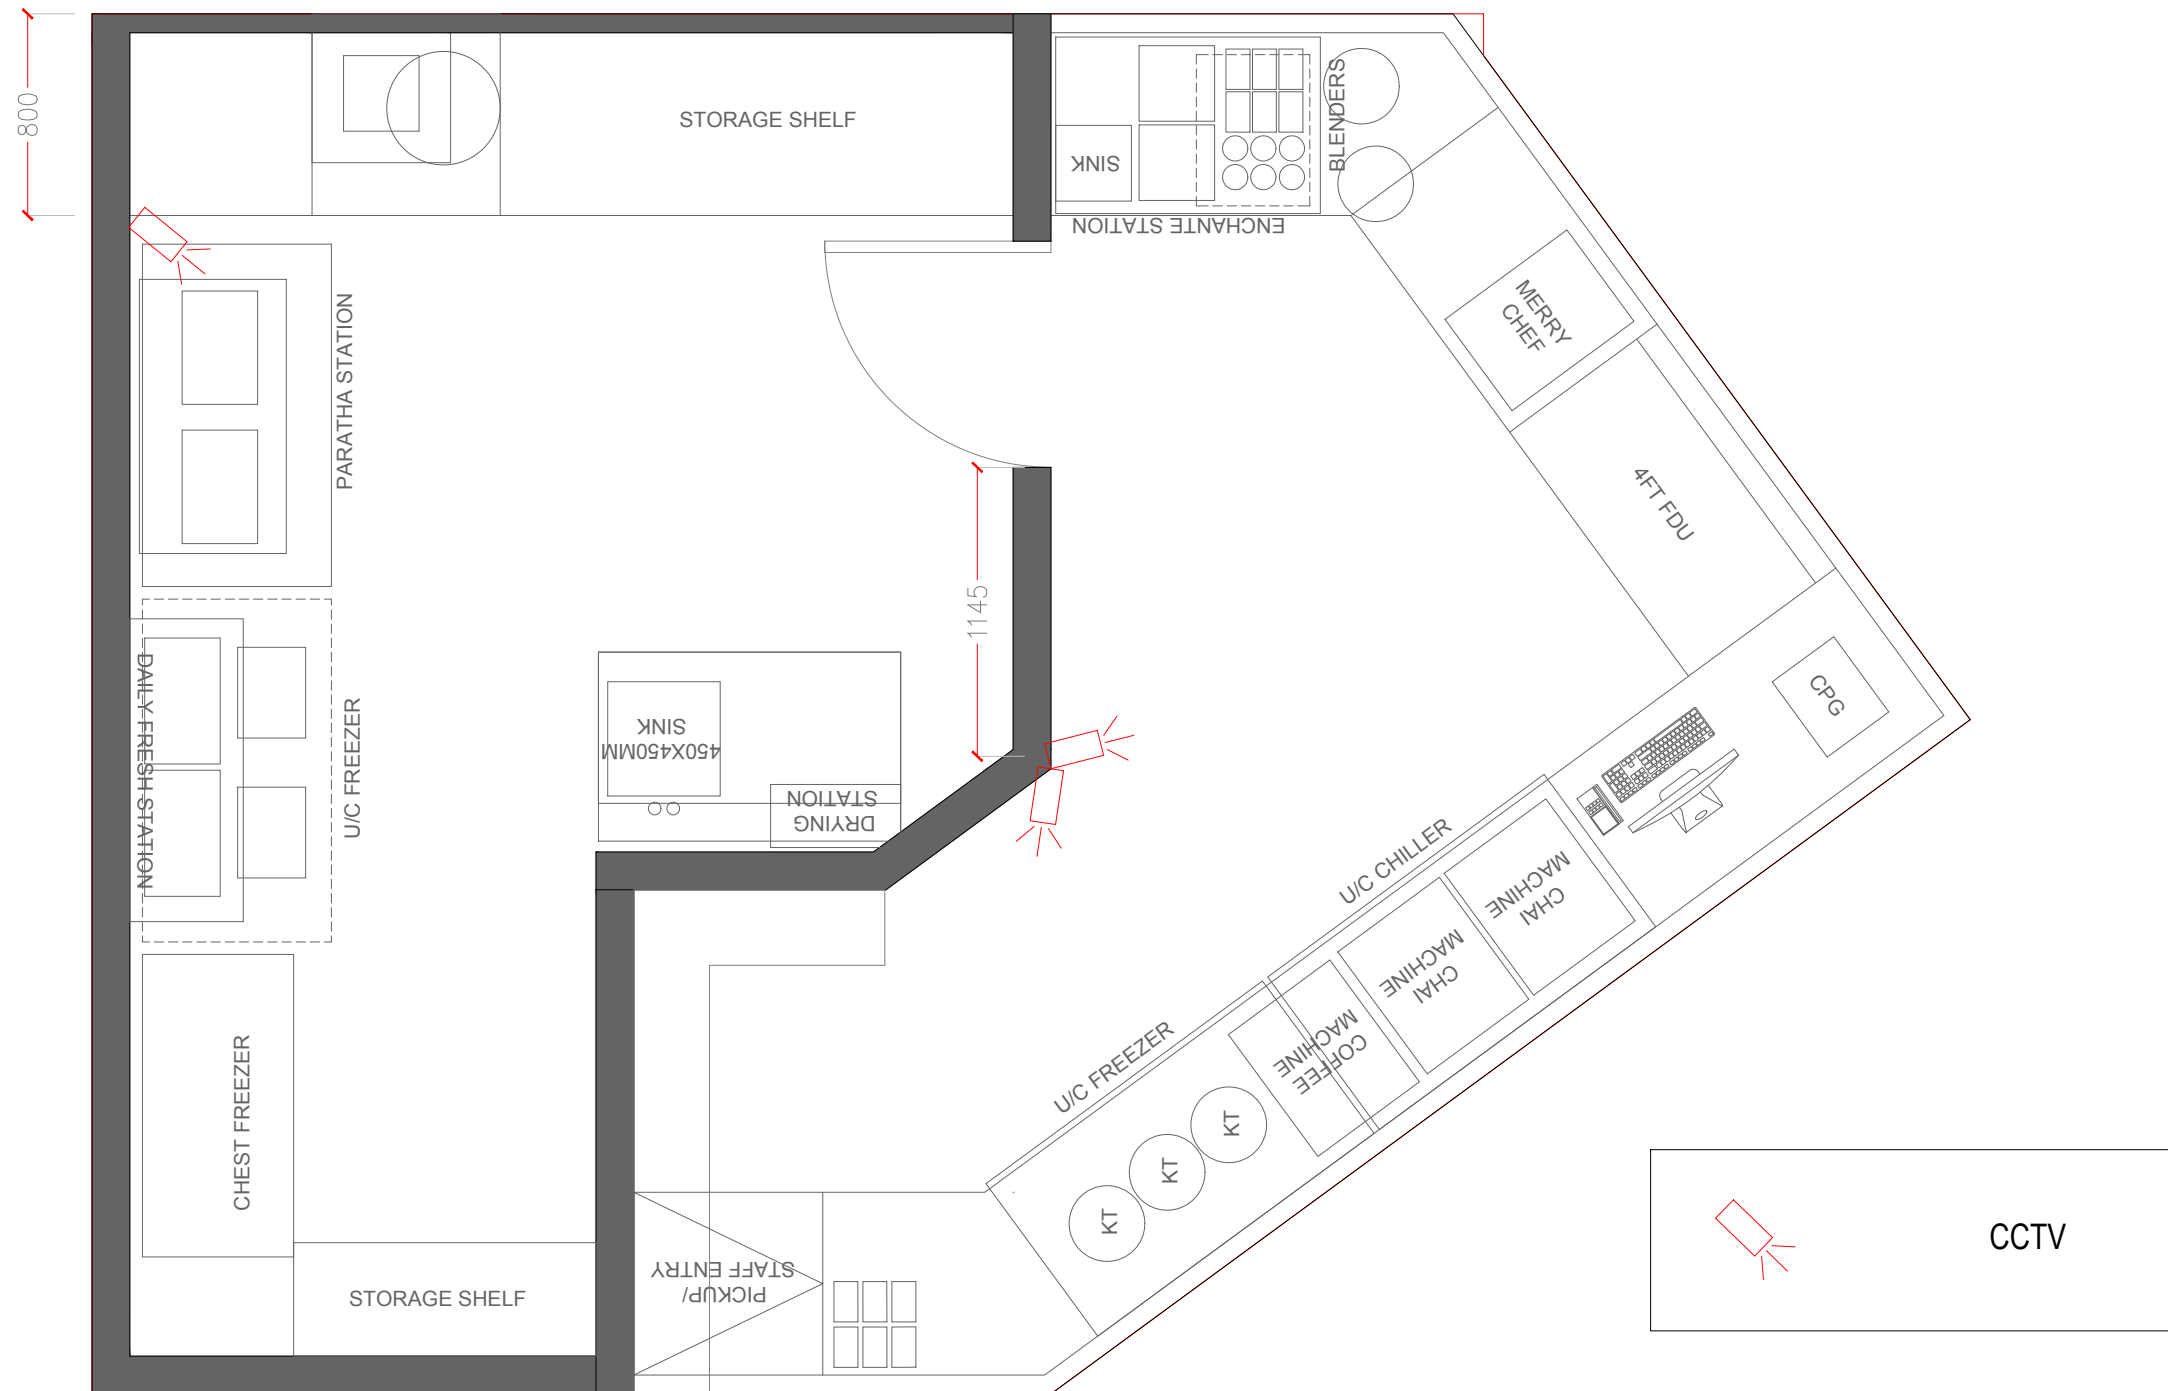

DRAWING TITLE

CCTV Layout

DRAWING NUMB.

A 122

SCALE

DATE

23.09.2024

DESIGN STAGE

Concept Design

REVISION

R3

Chai Point
Design



CHAI POINT


PROJECT

Chai Point
Noida Airport

GENERAL NOTES

ALL DIMENSIONS TO BE CHECKED ON SITE BY CONTRACTORS
DO NOT SCALE THE DRAWINGS
REPORT ANY DISCREPANCIES TO THE AUTHORS
ALL RIGHTS RESERVED BY THE AUTHOR

REVISION

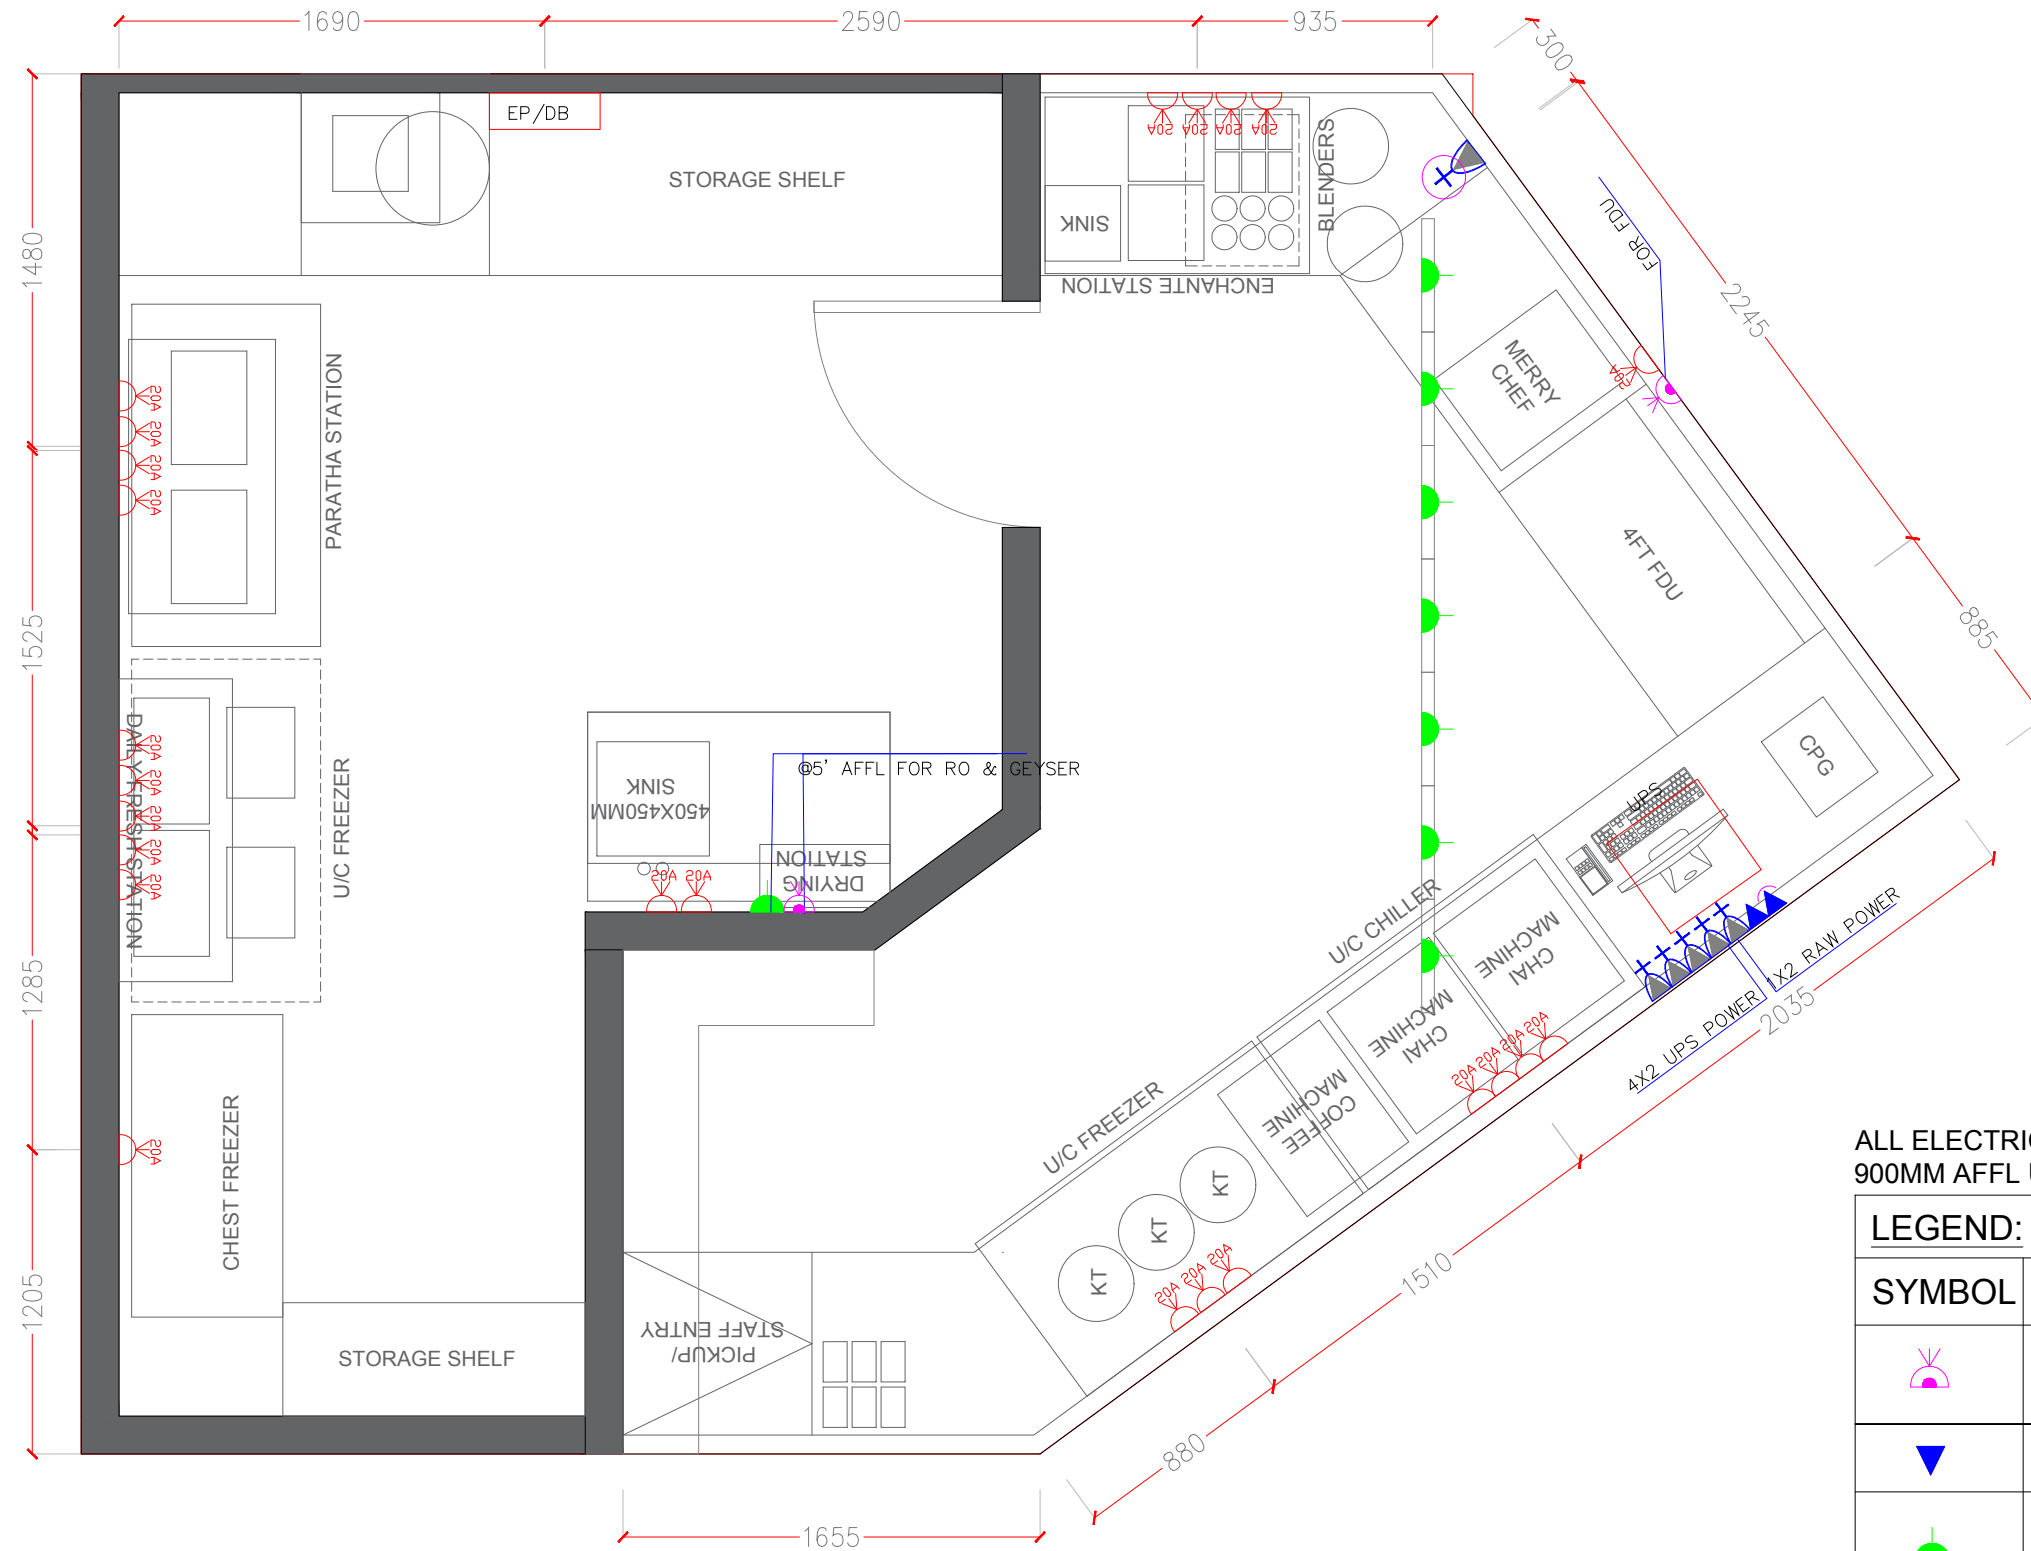

ALL ELECTRIC POINTS TO BE PROVIDED AT 900MM AFFL UNLESS MENTIONED OTHERWISE

LEGEND:	
SYMBOL	DESCRIPTION
	16A, (3 MODEL- 1 SWITCH, 1 SOCKET) SOCKET (RAW POWER)
	DATA SOCKET OUTLET (RJ-45)
	6A (3 MODEL- 1 SWITCH, 1 SOCKET) SOCKET (UPS POWER)
	20A (3 MODEL- 1 SWITCH, 1 SOCKET) INDUSTRIAL METAL CLAD SOCKET (RAW POWER) WITH 2 POLE MCB
	TELEPHONE POINT
	6A (6 MODEL- 2 SWITCH, 2 SOCKET) SOCKET (UPS POWER)
	6A (3 MODEL- 1 SWITCH, 1 SOCKET) WITH USB PORT (UPS POWER) @2' AFFL

DRAWING TITLE

Electrical Layout

DRAWING NUMB.

A 123

SCALE

DATE

23.09.2024

DESIGN STAGE

Concept Design

REVISION

R3

Chai Point
Design



CHAI POINT

PROJECT

Chai Point
Noida Airport

GENERAL NOTES

ALL DIMENSIONS TO BE CHECKED ON SITE BY CONTRACTORS
DO NOT SCALE THE DRAWINGS
REPORT ANY DISCREPANCIES TO THE AUTHORS
ALL RIGHTS RESERVED BY THE AUTHOR

REVISION



- L1 - RO water Output @ 6' height from FFL
- L2 - RO water inlet @ 6' height from FFL
- L3 - Geyser water outlet @ 6' height from FFL
- L4 - Geyser water inlet @ 6' height from FFL
- L5 - RO water to ice cube & coffee machine @ 1' height from FFL
- T1 - RO water tap on SS counter
- T2/T3 - hot and cold mixer on SS counter

DRAWING TITLE

Plumbing Layout

DRAWING NUMB.

A 124

SCALE

DATE

23.09.2024

DESIGN STAGE

Concept Design

REVISION

R3

Chai Point
Design



CHAI POINT


PROJECT

Chai Point
Noida Airport

GENERAL NOTES

ALL DIMENSIONS TO BE CHECKED ON SITE BY CONTRACTORS
DO NOT SCALE THE DRAWINGS
REPORT ANY DISCREPANCIES TO THE AUTHORS
ALL RIGHTS RESERVED BY THE AUTHOR

REVISION

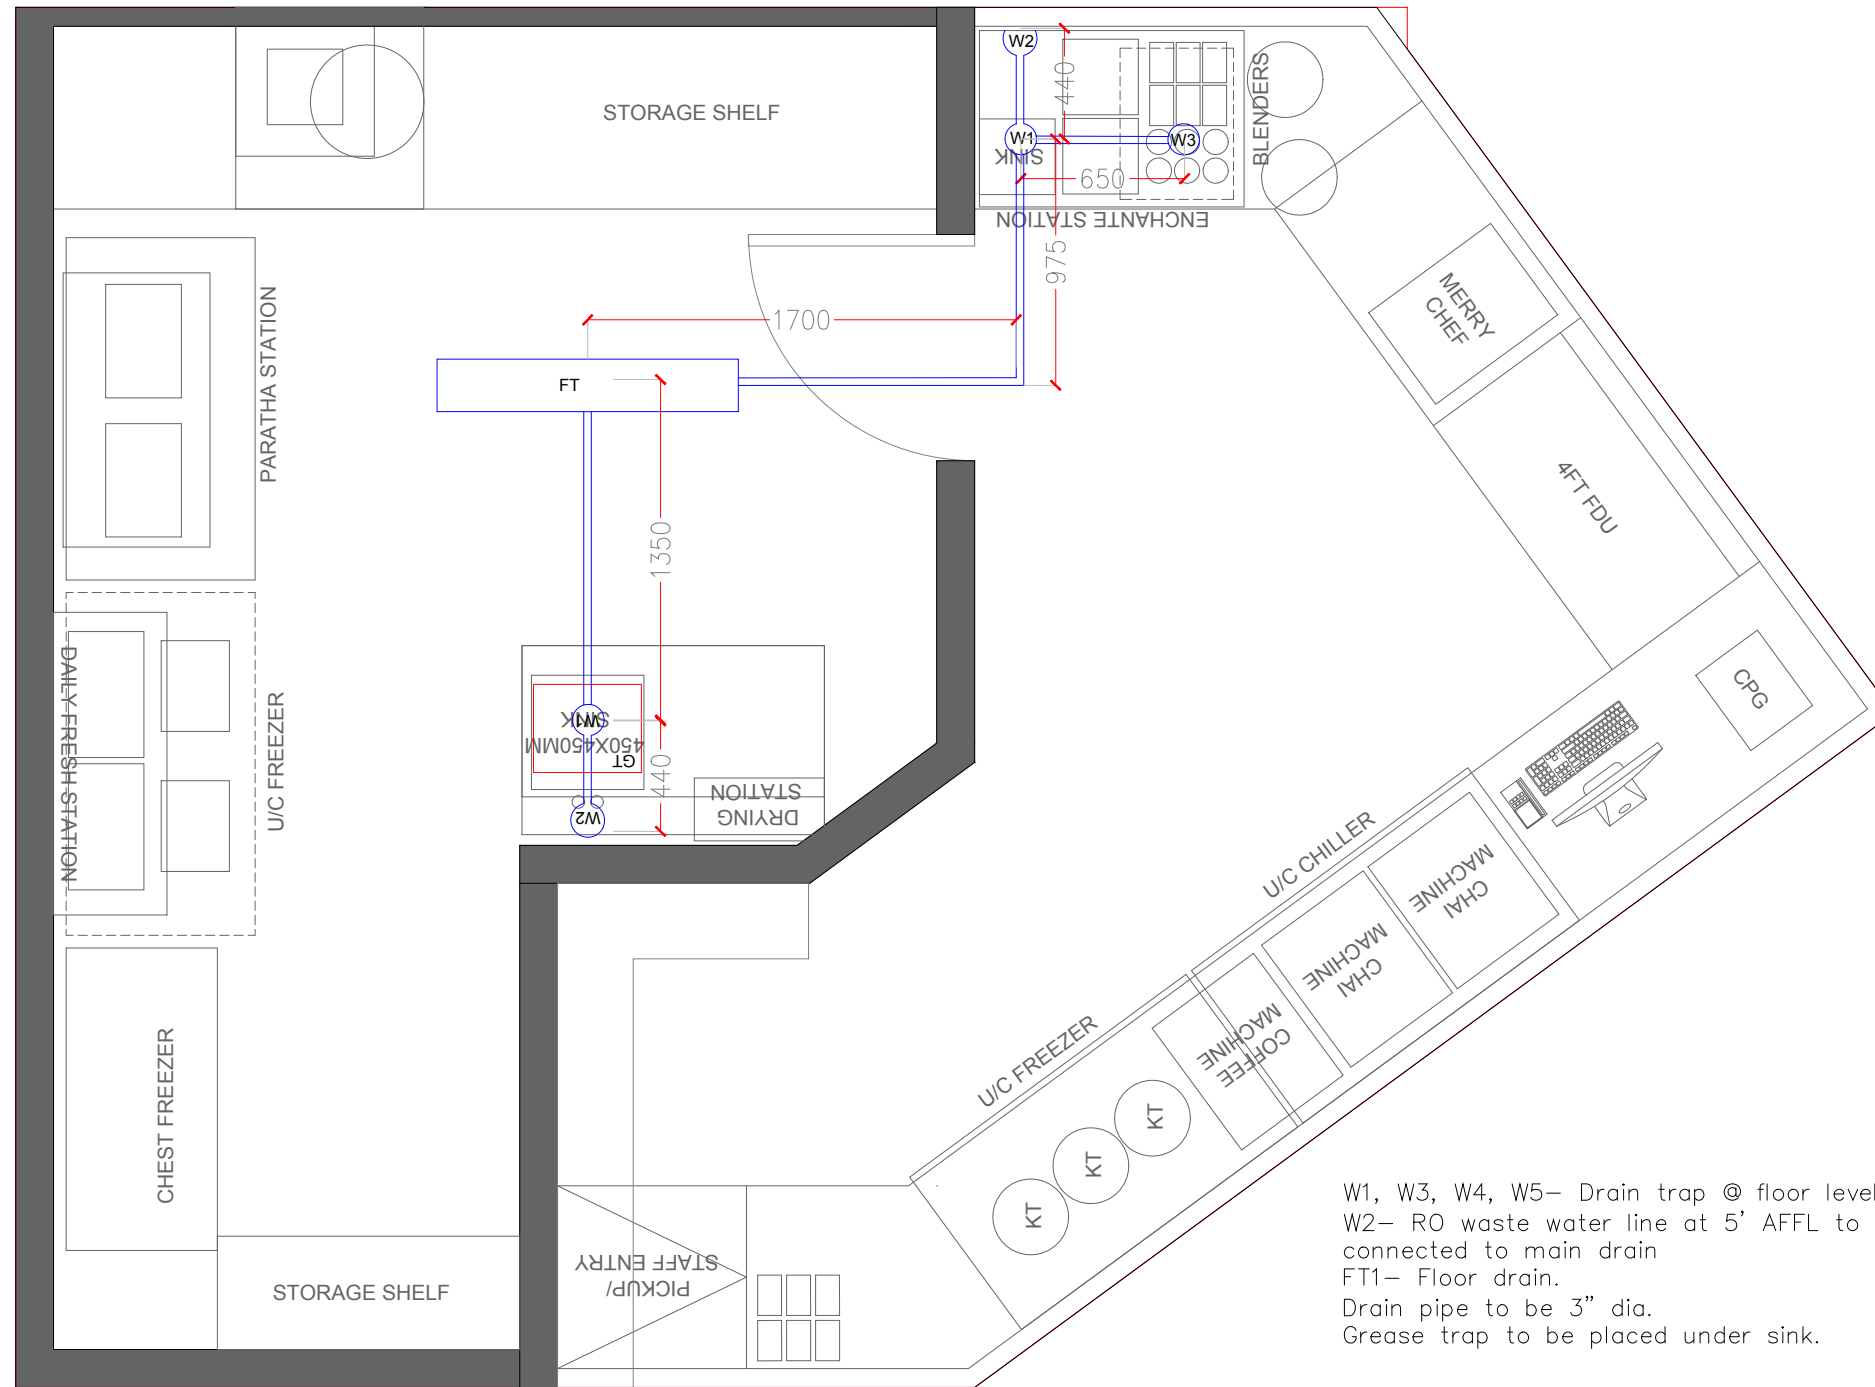

DRAWING TITLE

Drain Layout

DRAWING NUMB.

A 125

SCALE

DATE

23.09.2024

DESIGN STAGE

Concept Design

REVISION

R3

Chai Point
Design



CHAI POINT

PROJECT

Chai Point
Noida Airport

GENERAL NOTES

ALL DIMENSIONS TO BE CHECKED ON SITE BY CONTRACTORS
DO NOT SCALE THE DRAWINGS
REPORT ANY DISCREPANCIES TO THE AUTHORS
ALL RIGHTS RESERVED BY THE AUTHOR

REVISION

DRAWING TITLE

Counter Elevation

DRAWING NUMB.

A 126

SCALE

DATE

23.09.2024


DESIGN STAGE

Concept Design

REVISION

R3

Chai Point
Design

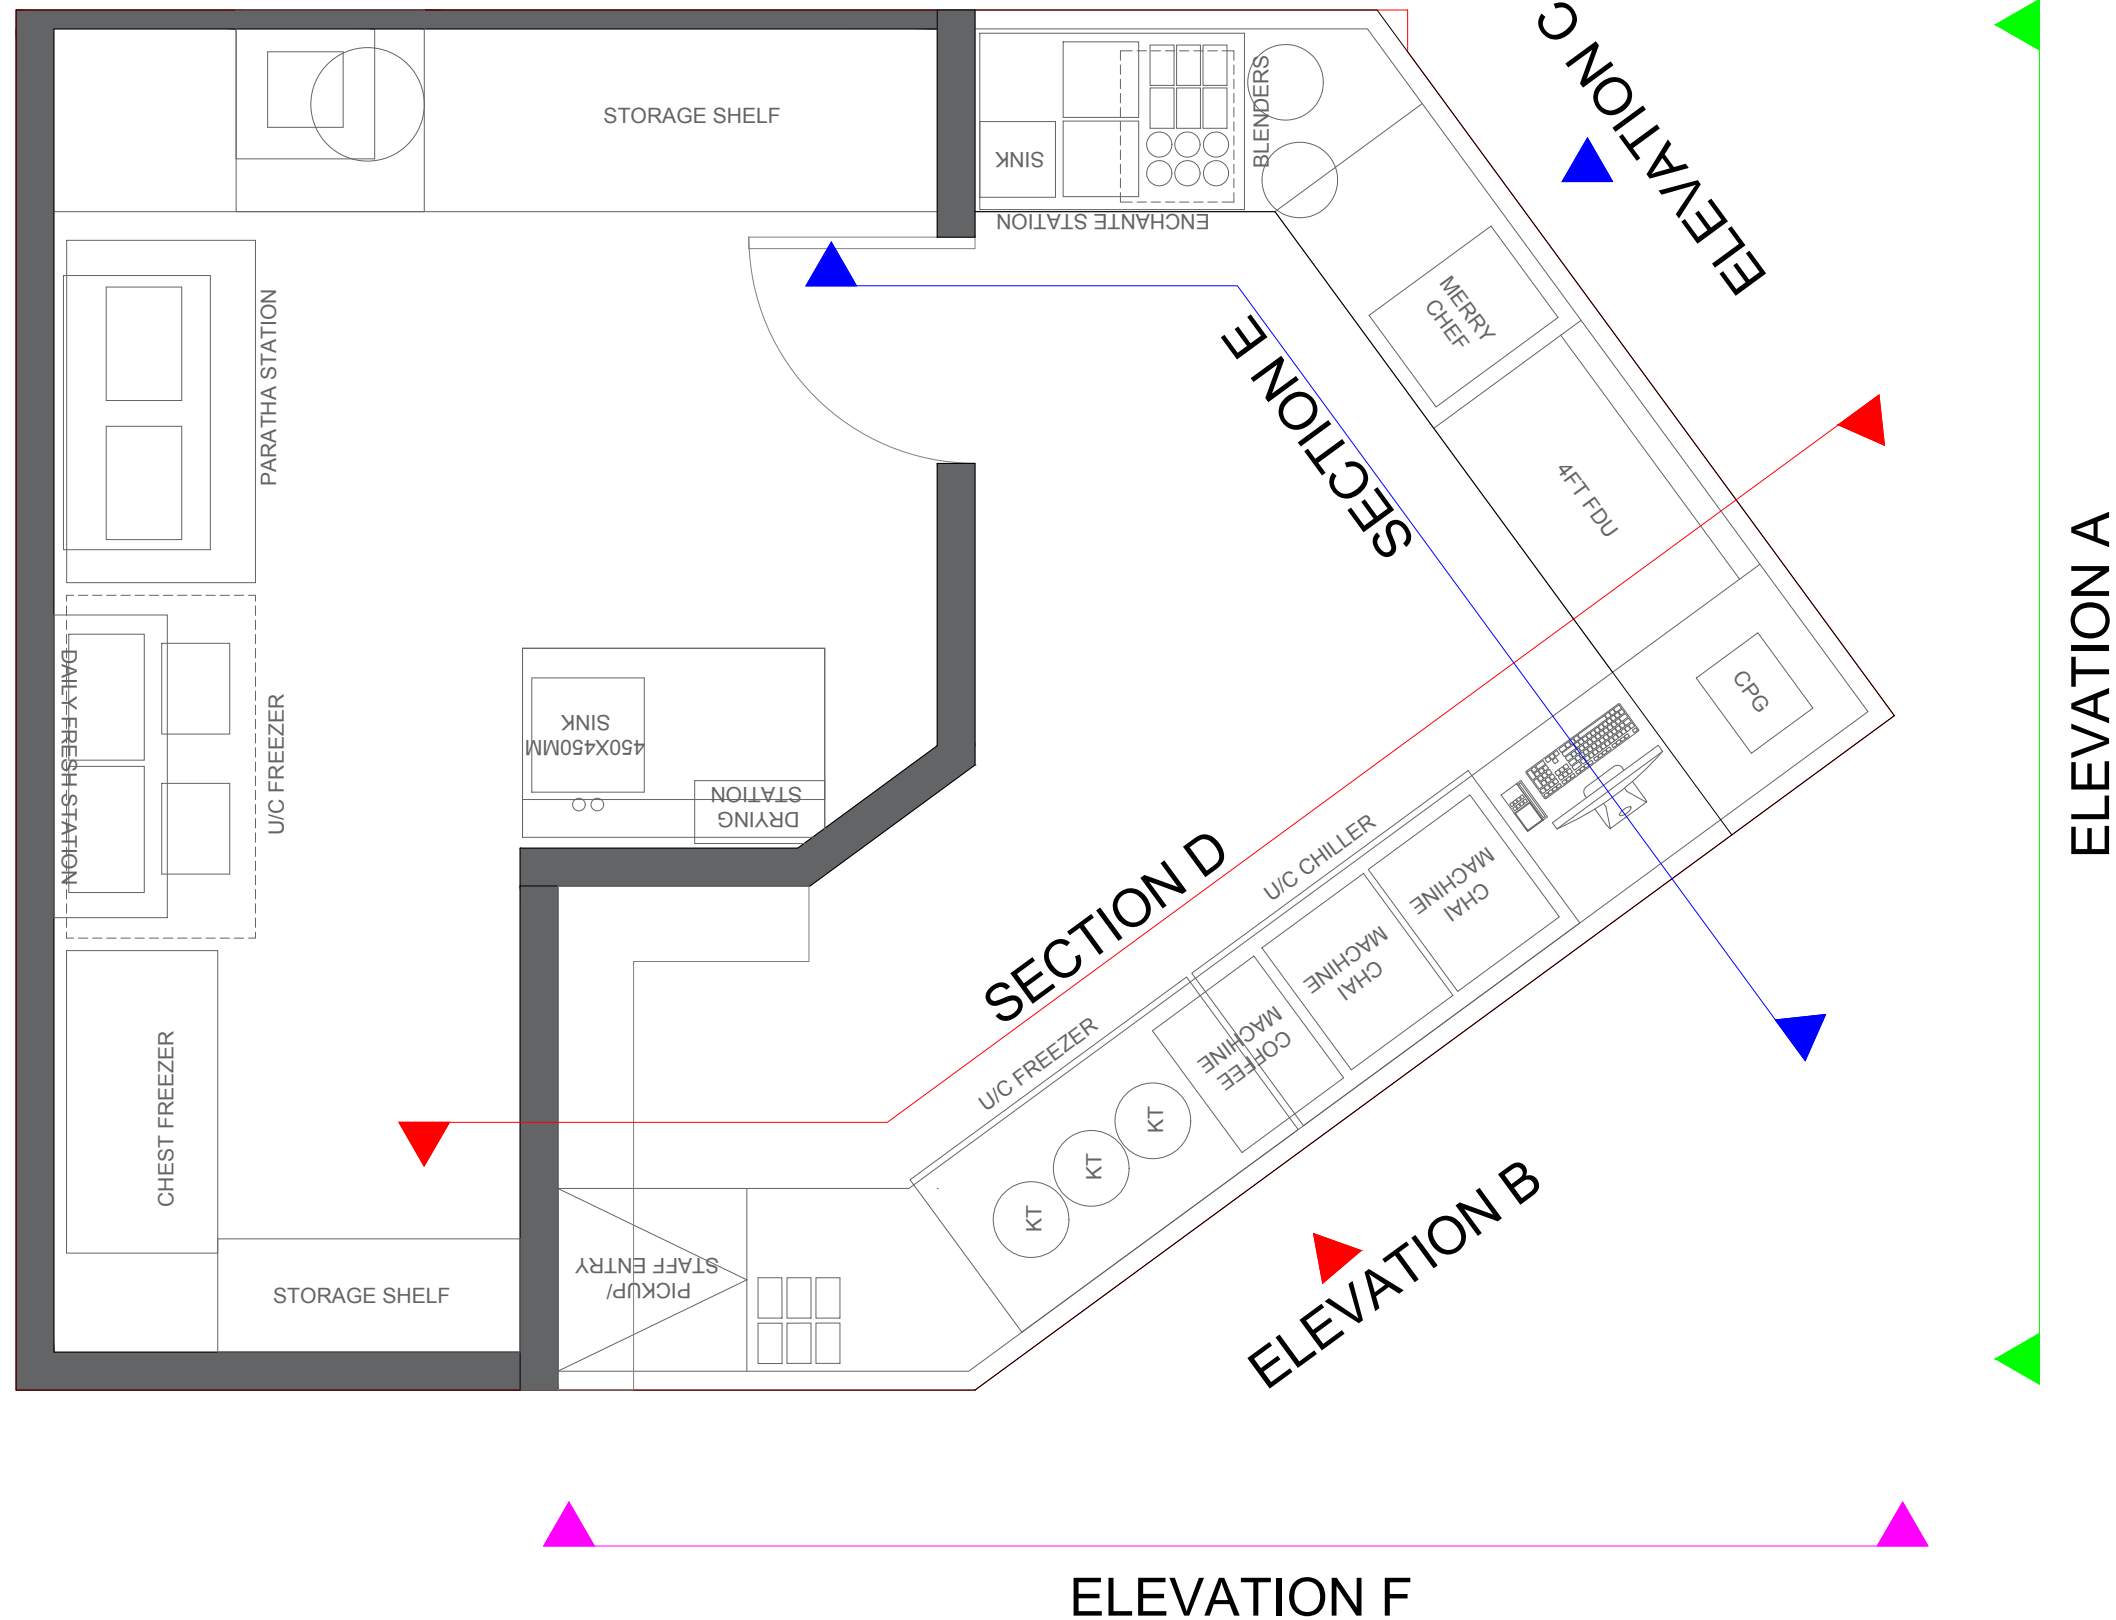



CHAI POINT


PROJECT

Chai Point
Noida Airport

GENERAL NOTES

ALL DIMENSIONS TO BE CHECKED ON SITE BY CONTRACTORS
DO NOT SCALE THE DRAWINGS
REPORT ANY DISCREPANCIES TO THE AUTHORS
ALL RIGHTS RESERVED BY THE AUTHOR

REVISION

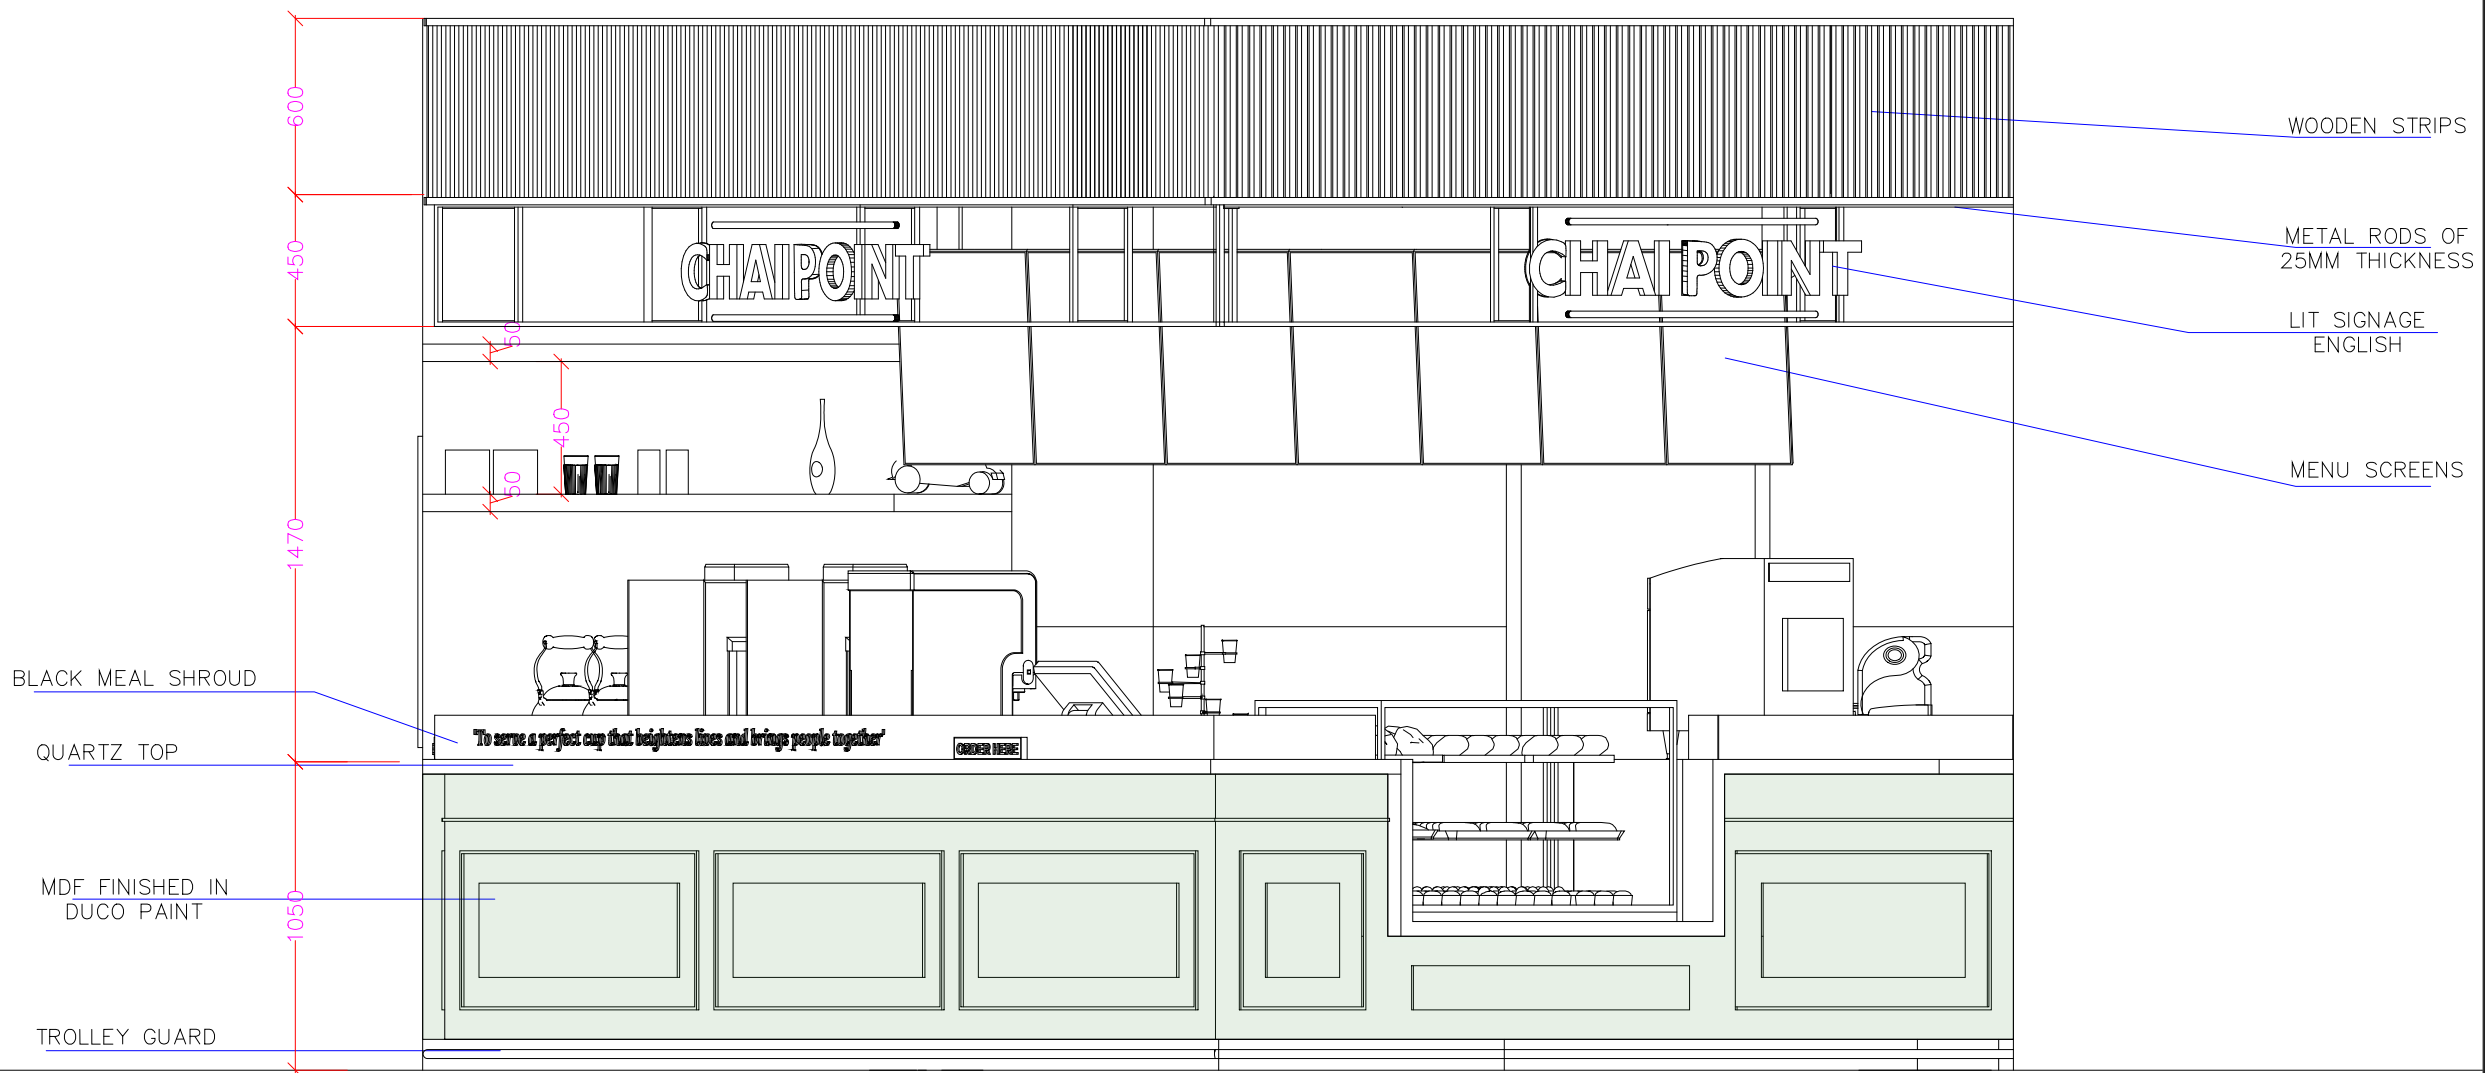

ELEVATION A

DRAWING TITLE

Front Elevation

DRAWING NUMB.

A 127

SCALE

DATE

23.09.2024

DESIGN STAGE

Concept Design

REVISION

R3

Chai Point
Design



CHAI POINT


PROJECT

Chai Point
Noida Airport

GENERAL NOTES

ALL DIMENSIONS TO BE CHECKED ON SITE BY CONTRACTORS
DO NOT SCALE THE DRAWINGS
REPORT ANY DISCREPANCIES TO THE AUTHORS
ALL RIGHTS RESERVED BY THE AUTHOR

REVISION

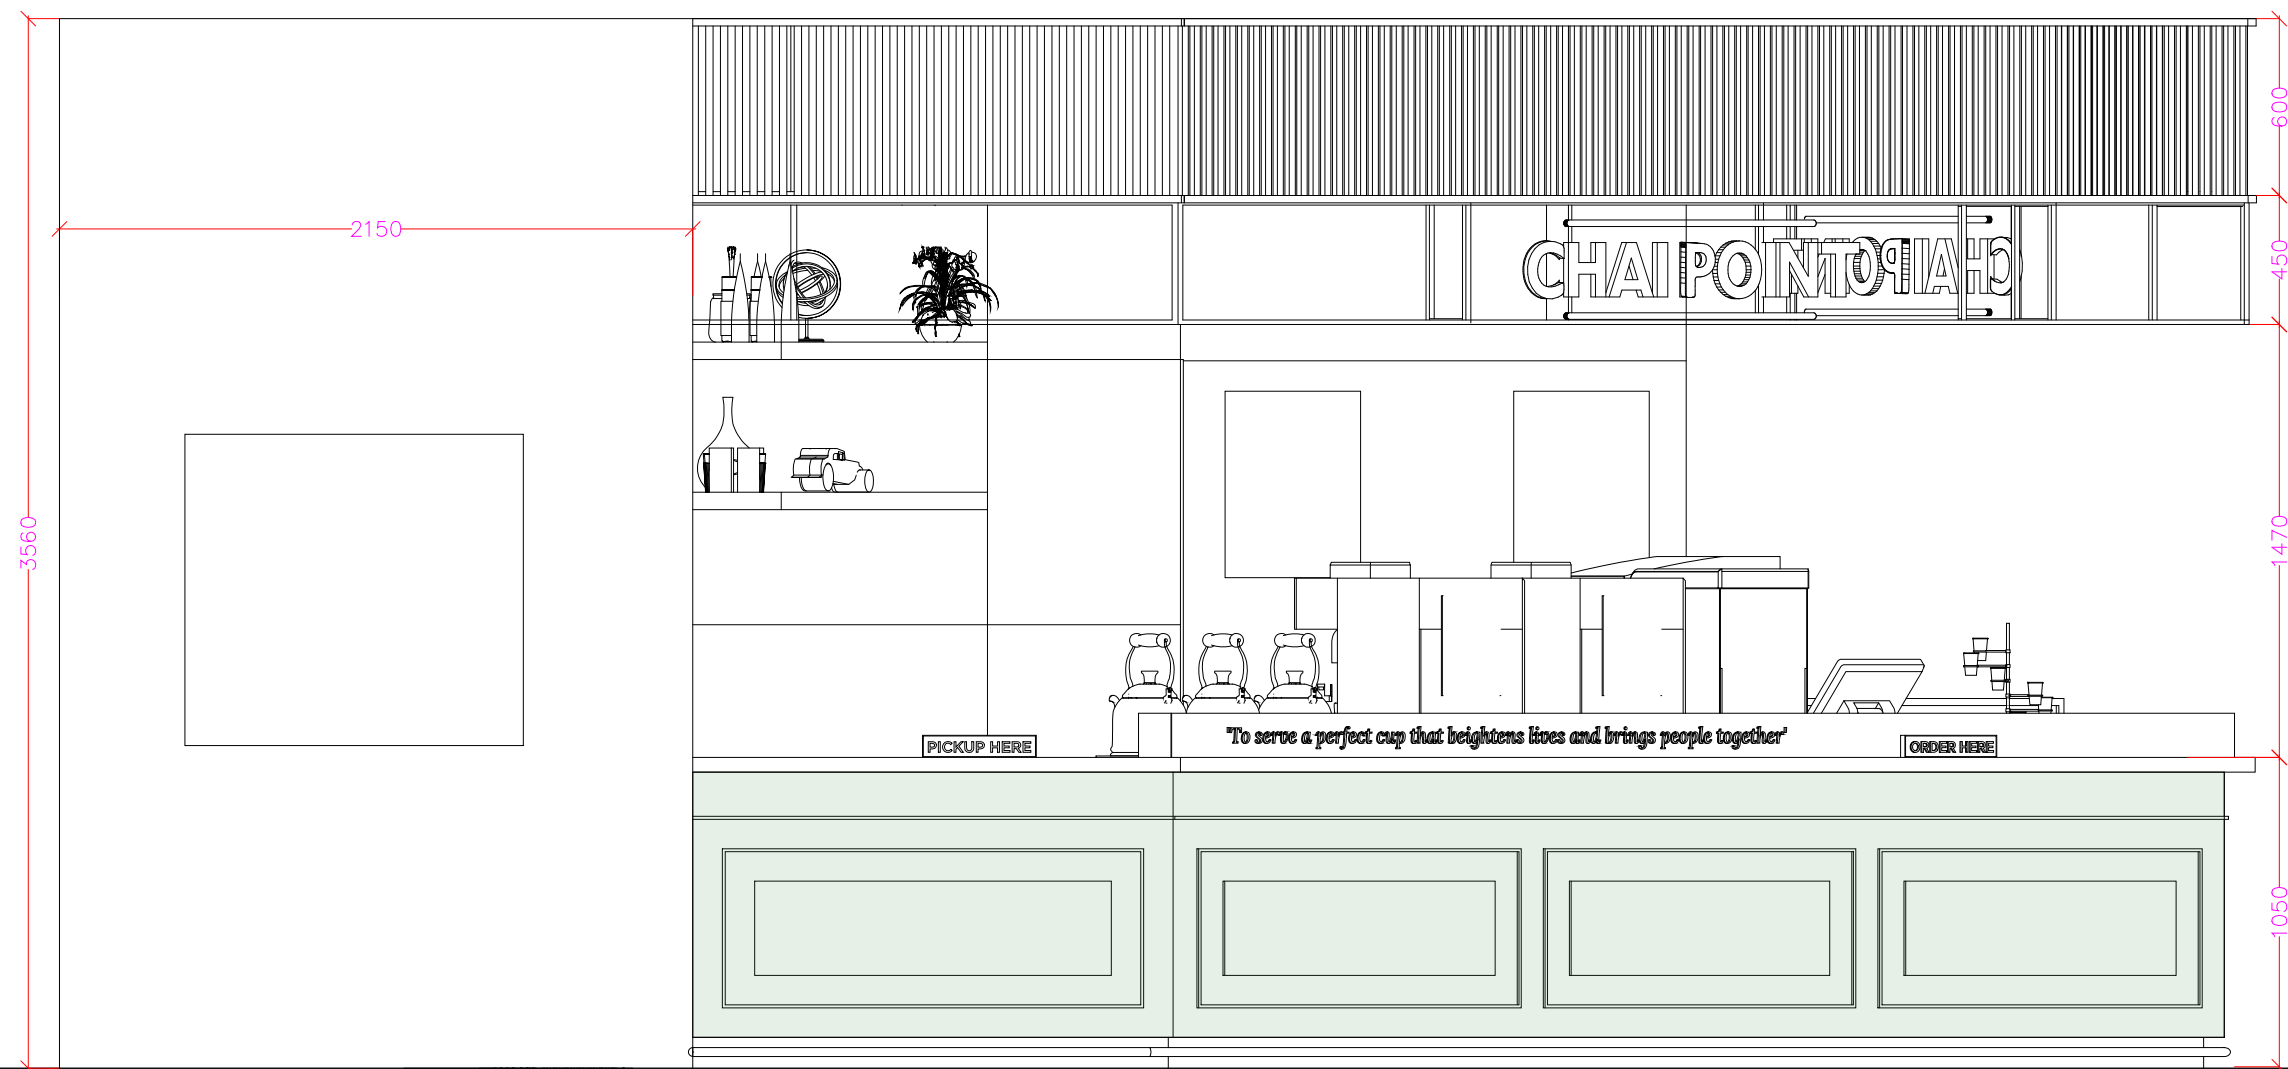

ELEVATION F

DRAWING TITLE

Front Elevation

DRAWING NUMB.

A 127

SCALE

DATE

23.09.2024

DESIGN STAGE

Concept Design

REVISION

R3

Chai Point
Design



CHAI POINT


PROJECT

Chai Point
Noida Airport


GENERAL NOTES

ALL DIMENSIONS TO BE CHECKED ON SITE BY CONTRACTORS
DO NOT SCALE THE DRAWINGS
REPORT ANY DISCREPANCIES TO THE AUTHORS
ALL RIGHTS RESERVED BY THE AUTHOR

REVISION

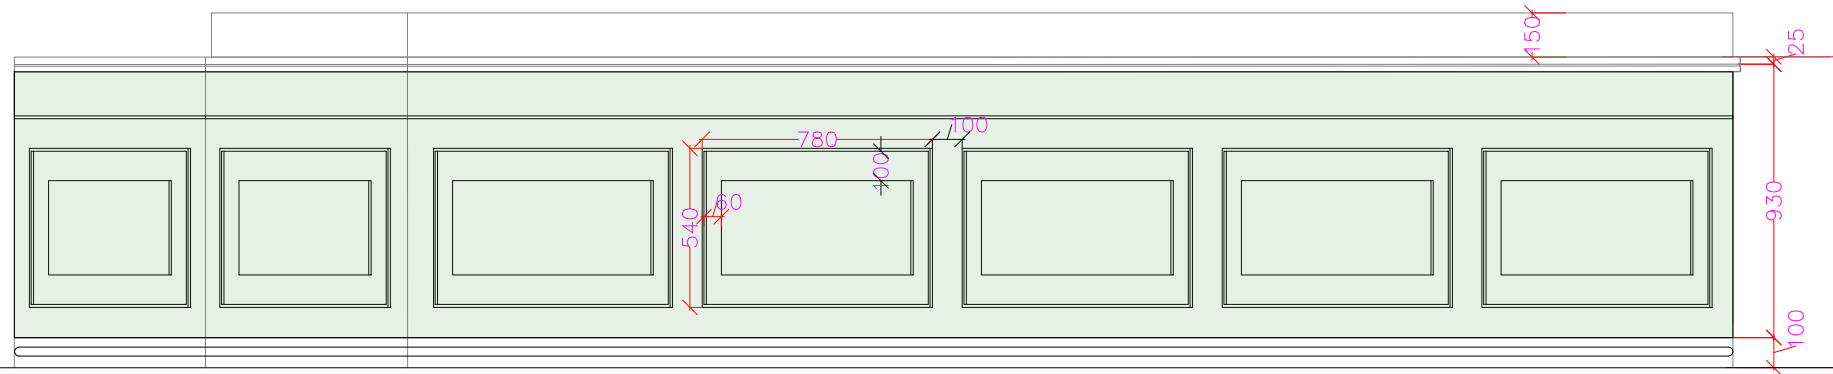

ELEVATION B

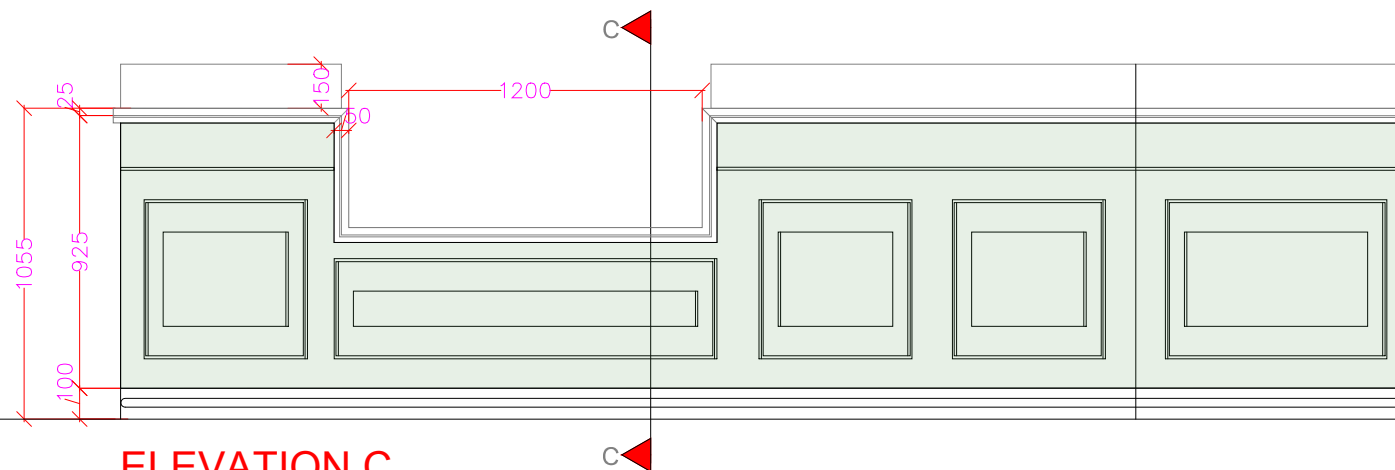

ELEVATION C

DRAWING TITLE

Counter Elevation

DRAWING NUMB.

A 128

SCALE

DATE

23.09.2024

DESIGN STAGE

Concept Design

REVISION

R3

Chai Point
Design



CHAI POINT


PROJECT

Chai Point
Noida Airport


GENERAL NOTES

ALL DIMENSIONS TO BE CHECKED ON SITE BY CONTRACTORS
DO NOT SCALE THE DRAWINGS
REPORT ANY DISCREPANCIES TO THE AUTHORS
ALL RIGHTS RESERVED BY THE AUTHOR

REVISION

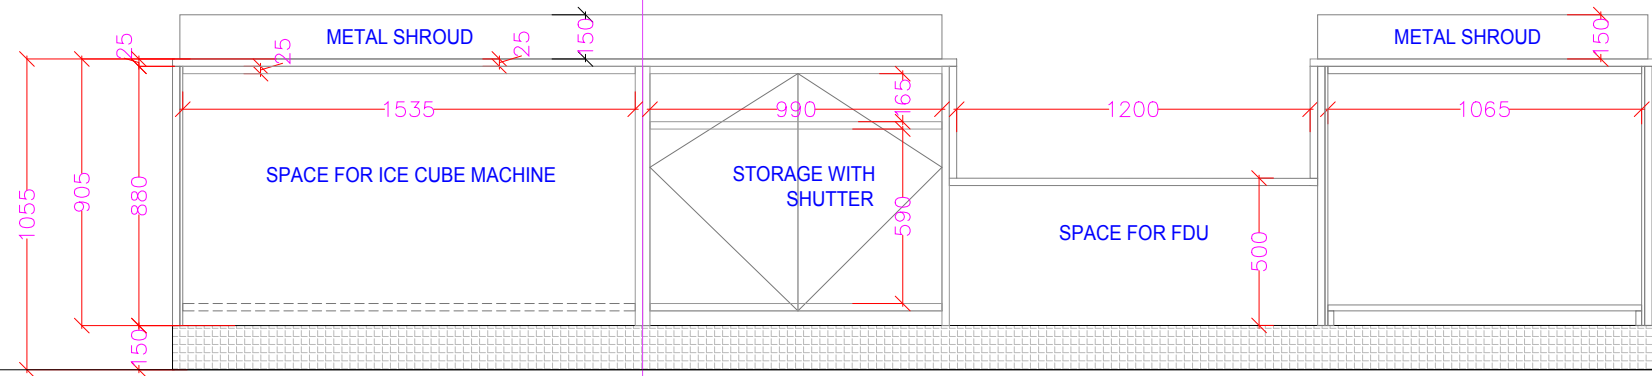

SECTION E

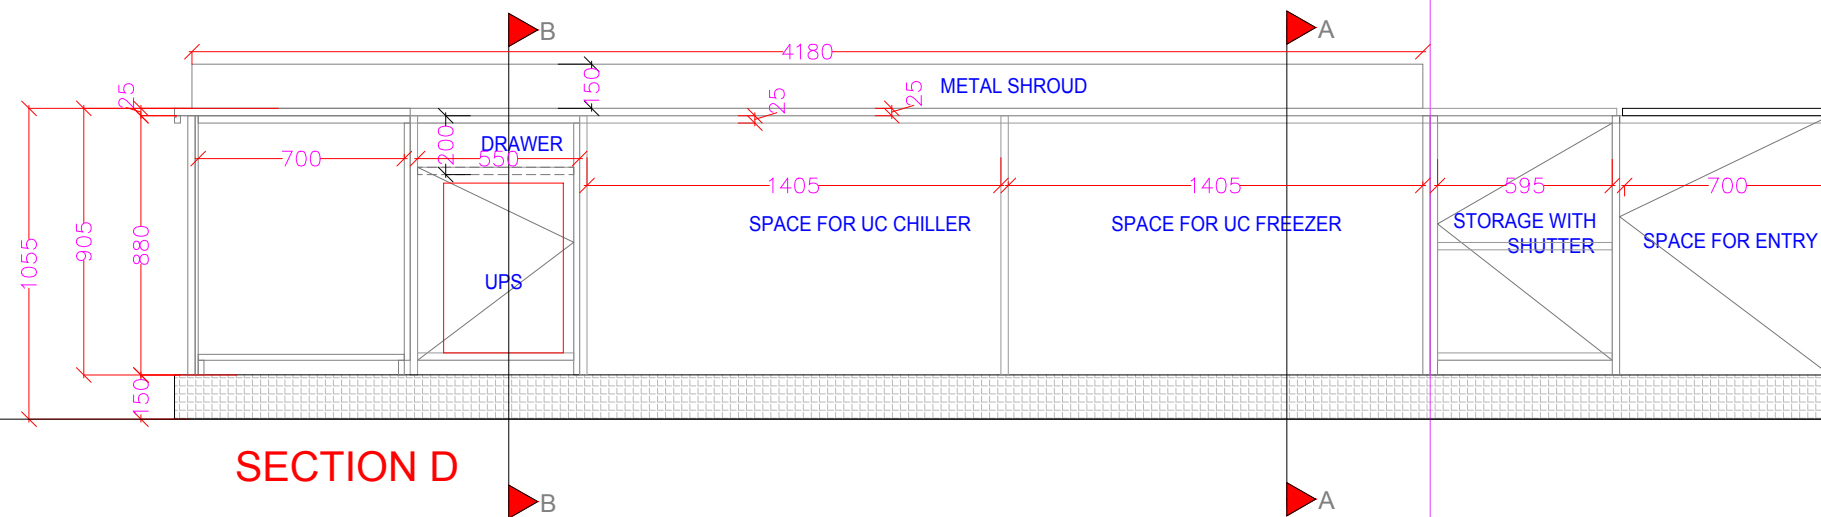

SECTION D

DRAWING TITLE

Counter Sections

DRAWING NUMB.

A 129

SCALE

DATE

23.09.2024

DESIGN STAGE

Concept Design

REVISION

R3

Chai Point
Design



CHAI POINT


PROJECT

Chai Point
Noida Airport

GENERAL NOTES

ALL DIMENSIONS TO BE CHECKED ON SITE BY CONTRACTORS
DO NOT SCALE THE DRAWINGS
REPORT ANY DISCREPANCIES TO THE AUTHORS
ALL RIGHTS RESERVED BY THE AUTHOR

REVISION

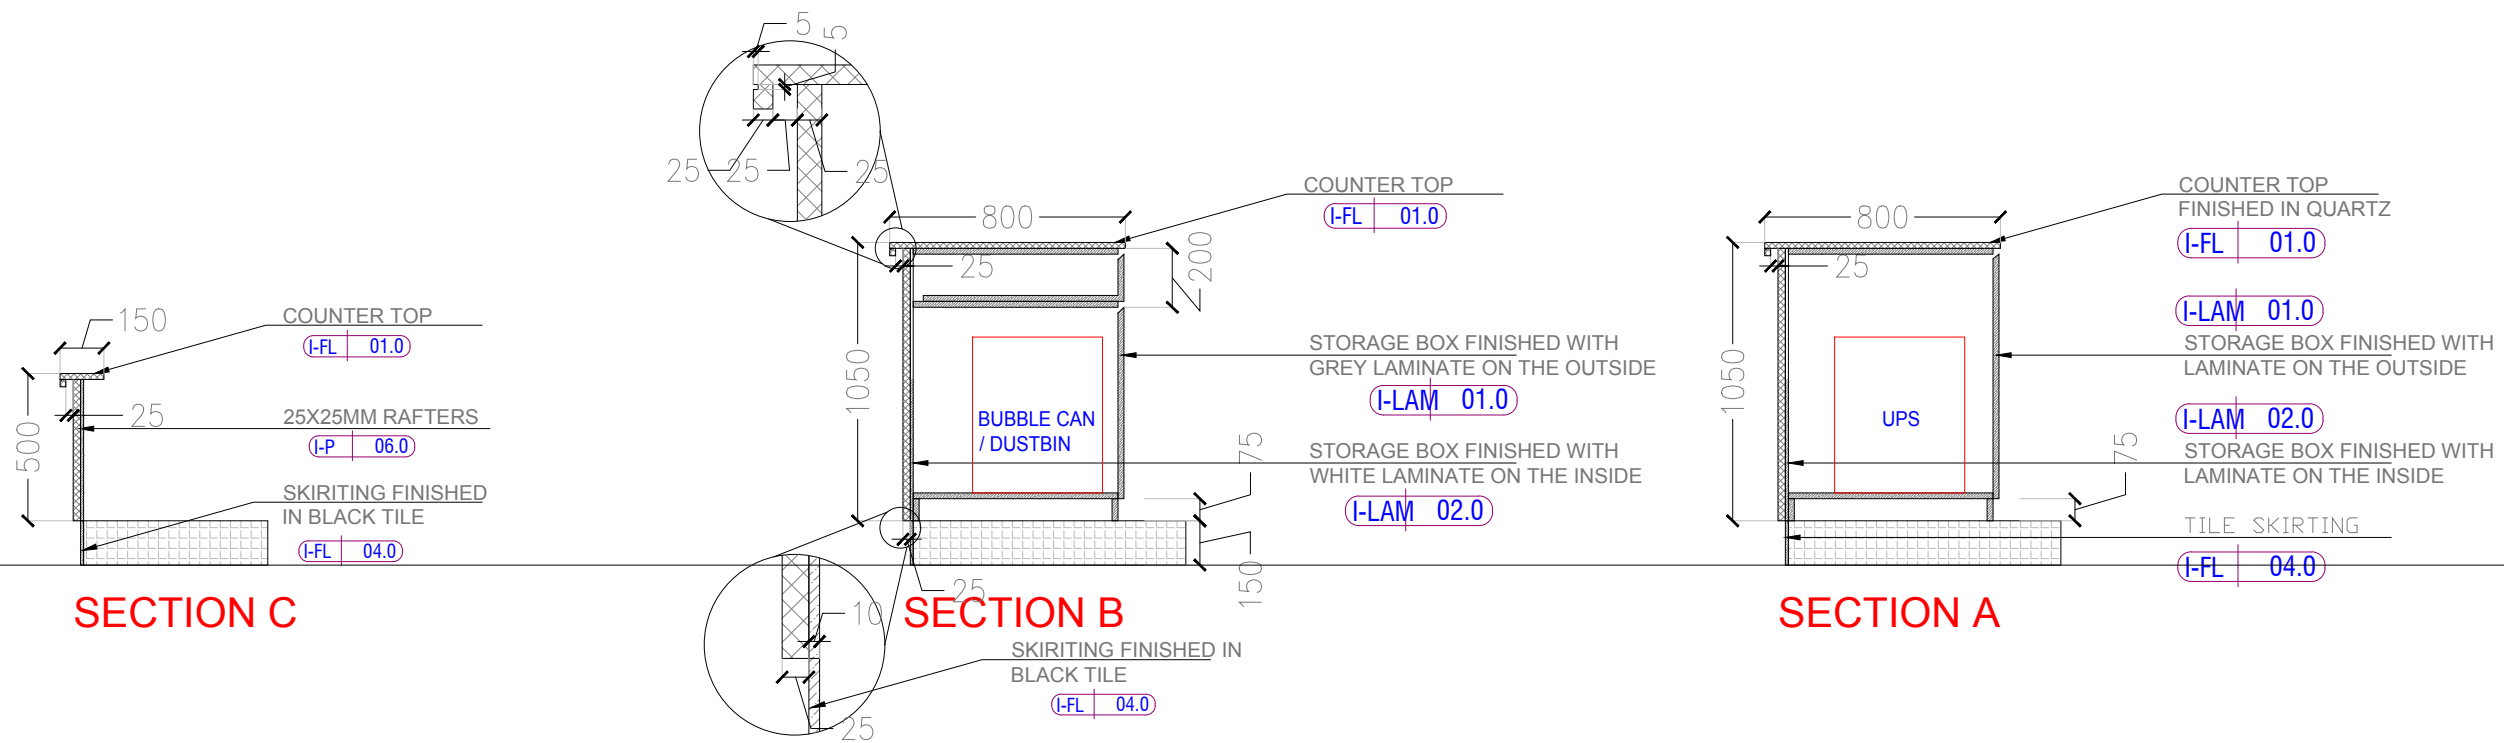

DRAWING TITLE

Counter Sections

DRAWING NUMB.

A 130

SCALE

DATE

23.09.2024

DESIGN STAGE

Concept Design

REVISION

R3

Chai Point
Design