



CARLSJR FF018

GMR INTERNATIONAL AIRPORT LIMITED, HYDERABAD

REV	DATE	DESCRIPTION	DRN	CHK
T02	11.10.24	TENDER		HOD NM
T01	23.04.24	TENDER		HOD NM



PROJECT
CARLSJR FF018
GMR INTERNATIONAL
AIRPORT LIMITED,
HYDERABAD

DRAWING TITLE
COVER SHEET

SCALE NTS DATE 11.10.2024 DRAWN HOD A3 SHEET

STATUS
TENDER

ORG	PROJECT NO	DRAWING TYPE	NUMBER	REV
TFS	0000	02GA	001	T02

GENERAL NOTES


ALL DIMENSIONS ARE IN MM UNLESS OTHERWISE MENTIONED.
DO NOT SCALE THE DRAWING.
FOLLOW WRITTEN DIMENSIONS ONLY. IN CASE OF ANY DISCREPANCY IN DIMENSIONS/DETAILS AT SITE, PLEASE REFER IT BACK TO THE ARCHITECT.

THE MAIN CONTRACTOR IS EXPECTED TO COORDINATE THE DESIGNS/SITE EXECUTION WITH THE DESIGNS/DETAILS/WORKS OF THE SUB-CONTRACTOR/ VENDOR (E.G. PLUMBING CONTRACTOR). IN CASE OF ANY DISCREPANCY IN DIMENSIONS/DETAILS AT SITE, PLEASE REFER IT BACK TO THE ARCHITECT.

THE DRAWINGS/ DETAILS PROVIDED ARE MEANT TO CLARIFY DESIGN INTENT/DESIGN APPEARANCE ONLY. THE CONTRACTOR IS EXPECTED TO DEVELOP HIS/HER OWN DETAILS TO ENSURE STRUCTURAL STABILITY/ FUNCTIONING OF THE DETAIL IN LINE WITH THE DESIGN INTENT GIVEN.

THE DRAWINGS/DETAILS PROVIDED DO NOT CONTAIN ANY IRONMONGERY (E.G. HINGES, SCREWS, ANGLES ETC.) SPECIFICATIONS OR DETAILS. IT IS EXPECTED THE CONTRACTOR WILL SUITABLY DETAIL THE BUILD-UPS WITH THE RIGHT FITTINGS/IRONMONGERY TO ENSURE STRUCTURAL STABILITY/ FUNCTIONING OF THE DETAIL IN LINE WITH THE DESIGN INTENT GIVEN.
ALL SHOP DRAWINGS, MAKE/MATERIAL, FIXTURES TO BE PRESENTED TO ARCHITECT FOR REVIEW AND VALIDATION.
ALL TAP-OFF POINTS (E.G. FOR POWER, WATER, DRAINAGE ETC.) TO BE VALIDATED AT SITE PRIOR TO COMMENCEMENT OF WORK.

SYMBOLS & ABBREVIATIONS

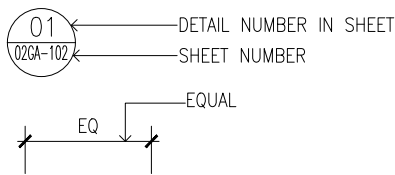

AIRPORT FFL- REFERS TO EXISTING FINISHED FLOOR LEVEL OF AIRPORT

COUNTER TOP								
20	SU01	COUNTER TOP, COUNTER FASCIA	SOLID SURFACE	WHITE DIAMOND COUNTER TOP	MATTE	SILESTONE	https://www.elitegraniteni.com/silestone/	
21	SU02	BAR COUNTER TOP	SOLID SURFACE	DEEP TITANIUM COUNTER TOP	GLOSSY	CORIAN-DEEP TITANIUM	https://www.corian.com/	
FLOORING								
22	FL01	FLOOR (SEATING AREA)	CONCRETE	600X1200 MM CONCRETE CERAMIC FLOOR TILE	MATTE	RAK-WHITE COLLECTIONS CODE: A12GLFC-SR.M6XSR	https://www.rakceramics.com/usa/en/tiles-floors-coverings/collections/oft-concrete/	
23	FL02	FLOOR (SERVERY & BKH)	KOTA STONE	540X540MM GREY COLOUR KOTA STONE	MATTE	KOTA STONE	https://www.kotastone.com/blue-kotastone-wholesale-exporters.html	
24	FL03	FLOOR TRIM	STAINLESS STEEL	S.S 304 GRADE T-SHAPE TRANSITION TRIM	MATTE	SDS-PROFILES /EQUIVALENT	https://sdsprofile.com/product/s304-t-patt-t-profile-now-available-in-pune-sds-brand/	
25	FL04	FLOOR TRIM	STAINLESS STEEL	SS FLOOR REDUCER TRIM	MATTE	AAMTAC-METAL PROFILES REDUCER TRIM	https://aamtac.com/metallic-profiles-trims/	
WALL TILES								
26	WT01	WALL	CERAMIC TILE	300x600 MM WOODEN EFFECT CERAMIC WALL TILE	MATTE	NITCO/EQUIVALENT	https://www.nitco.in/product-details/wooden-wall-tiles/kenridge-brown/nitiwaul600x300nosm05279	
27	WT02	WALL(BKH)	CERAMIC TILE	100X300 MM CERAMIC TILES WITH 1MM SPACER, GROUTED WITH GREY COLOUR EPOXY	GLOSSY	RAK-WHITE COLLECTIONS CODE: A13WSUB4WHE.G0X0U	https://www.rakceramics.com/uk/en/tiles-floors-coverings/collections/subway/	
WALL PAPER								
28	GR01	WALL, SERVERY BULKHEAD	WALL PAPER	GEOMETRIC PATTERN VINYL WALL COVERINGS	MATTE	LOCALLY SOURCED	NA	
UPHOLESTRY								
29	UP01	BOOTH SEAT	FAUX LEATHRE	GREY COLOUR LEATHRETTIE	MATTE	LOCALLY SOURCED	NA	

FINISHES SCHEDULE								
#	FINISH CODE	SURFACE	FINISH TYPE	DESCRIPTION/DETAIL	FINISH	REFERENCE/BRAND	WEBLINK	IMAGE
ALL MATERIAL / PAINTS TO BE FIRE RATED AS PER AIRPORT REQUIREMENT								
WALL PANEL/CLADDING								
1	WP01	WALL	WALL PANEL	OLD WHITE BRICK IMITATION PANELS/CLADDING	MATTE	STONE PANEL MODEL:532	https://www.stone-panel.co.uk/faux-brick-wall-panelling/	
2	WP02	WALL	WALL PANEL	GREY PAINTED BRICK IMITATION PANELS/CLADDING	MATTE	STONE PANEL	https://www.stone-panel.co.uk/faux-brick-wall-panelling/	
PAINT								
3	PT01	BULKHEAD	ENAMEL	TRAFFIC RED COLOUR PAINT RAL3020	MATTE	BRAND: SHERWIN-WILLIAMS /EQUIVALENT	https://www.sherwin-williams.com/en-us/color	
4	PT02	BULKHEAD, CEILING ELEMENT, STENCIL ARTWORK	ENAMEL	TRAFFIC YELLOW COLOUR PAINT RAL1023	MATTE	DULUX TRADE PAINT/ EQUIVALENT	https://www.dulux.in/en/colour-palettes/yellow-ferroc-1114209	
5	PT03	METAL FRAMES, DOOR, CONDIMENT UNIT	ENAMEL	GREY COLOUR PAINT RAL7022	MATTE	DULUX TRADE PAINT/ EQUIVALENT	https://www.duluxtradepaintexpert.co.uk/en/products/dulux-trade-vinyl-soft-sheen/ccid_1780528?size=2.5L	
6	PT04	GYPSUM CEILING, WALL(BKH), BULKHEAD, COLUMN	EMULSION	GREY COLOUR PAINT RAL7022	MATTE	DULUX TRADE PAINT/ EQUIVALENT	https://www.duluxtradepaintexpert.co.uk/en/products/dulux-trade-vinyl-soft-sheen/ccid_1780528?size=2.5L	
7	PT05	STENCIL ARTWORK	ENAMEL	JET BLACK COLOUR PAINT RAL9005	MATTE	DULUX TRADE PAINT/ EQUIVALENT	https://www.duluxtradepaintexpert.co.uk/en/products/dulux-trade-vinyl-soft-sheen/ccid_1780569?size=2.5L	
8	PT06	COLUMNS	EMULSION	WHITE COLOUR PAINT RAL9001/9016	MATTE	BRAND: SHERWIN-WILLIAMS /EQUIVALENT	https://www.sherwin-williams.com/en-us/color/color-family/white-paint-colors/sw9541-white-snow	
9	PT07	BULKHEAD, CEILING	ENAMEL	IVORY COAST COLOUR PAINT RAL1015	MATTE	DULUX TRADE PAINT/ EQUIVALENT	https://www.dulux.in/en/colour-palettes/ivory-coast-1114248	
LAMINATE								
10	LM01	PLANTER BOX, BOOTH SEAT, L SHAPED 2 TOP HIGH TABLE	LAMINATE	OAK WOOD LAMINATE	MATTE	MERINO-GOLDEN SCURO OAK DESIGN: 14974	https://www.merinolaminates.com/en/design/14974-antuga-ohio-oak/	
11	LM02	INNER FASCIA	LAMINATE	GREY COLOUR LAMINATE	MATTE	CENTURY-GREY CODE: E80232	https://www.centuryply.com/centurylaminates/single.php?productid=562	
12	LM03	PLANTER BOX TOP, PERCH TABLE TOP	LAMINATE	REFRESH OAK WOOD LAMINATE	MATTE	GREENLAM LAMINATES CODE: E427	https://www.greenlam.co.in/sanganer-pearl	
13	LM04	BAR -WALL MOUNTED SHELF, BAR-FRONT AND REAR COUNTER	LAMINATE	DARK GREY COLOUR LAMINATE	MATTE	GREENLAM LAMINATES CODE: E427	https://www.greenlam.co.in/sanganer-pearl	
METAL								
14	MT01	SKIRTING	POWDER COAT	GREY COLOUR POWDER COATED METAL SKIRTING RAL7022	MATTE	LOCALLY SOURCED	NA	
15	MT02	CONDIMENT UNIT	ALUMINIUM CORRUGATED SHEET	GREY COLOUR POWDER COATED ALUMINIUM CORRUGATED SHEET	MATTE	LOCALLY SOURCED	NA	
16	MT03	BULKHEAD	ALUMINIUM	6X30 M/MATHK ALUMINIUM SLATS FINISH WITH (PT01, PT02, PT07)	MATTE	LOCALLY SOURCED	NA	
17	MT04	CEILING	ALUMINIUM	20X30 M/MATHK ALUMINIUM SLATS FINISH WITH (PT07)	MATTE	LOCALLY SOURCED	NA	
18	MT05	PERCH TABLE	METAL MESH	METAL MESH FINISH WITH GREY COLOUR PAINT (PT03)	MATTE	LOCALLY SOURCED	NA	
19	MT06	BAR-FRONT COUNTER	METAL MESH	YELLOW COLOUR POWDER COATED METAL MESH RAL1023	MATTE	LOCALLY SOURCED	NA	

ALL DIMENSIONS MUST BE CHECKED ON SITE
INFORM THE ARCHITECT OF ANY DISCREPANCIES PRIOR TO CONSTRUCTION

NOTE: CONTRACTOR TO PROVIDE PHYSICAL SAMPLE FOR AIRPORT APPROVAL PRIOR INSTALLATION/FIXING

T02	11.10.24	TENDER	HOD	NM
T01	23.04.24	TENDER	HOD	NM
REV	DATE	DESCRIPTION	DRN	CHK



PROJECT
CARLSJR FF018
GMR INTERNATIONAL
AIRPORT LIMITED,
HYDERABAD

DRAWING TITLE
GENERAL NOTES & FINISHES
SCHEDULE


SCALE: NTS DATE: 11.10.2024 DRAWN: HOD A3 SHEET

STATUS
TENDER

ORG PROJECT NO DRAWING TYPE NUMBER REV
TFS 0000 02GA 003 T02

ALL DIMENSIONS MUST BE CHECKED ON SITE
INFORM THE ARCHITECT OF ANY DISCREPANCIES PRIOR TO CONSTRUCTION

- INDICATES UNIT DEMISE
- INDICATES PROPOSED SIGNAGE
- INDICATES SUSPENDED PROPOSED SIGNAGE
- INDICATES STENCIL ART

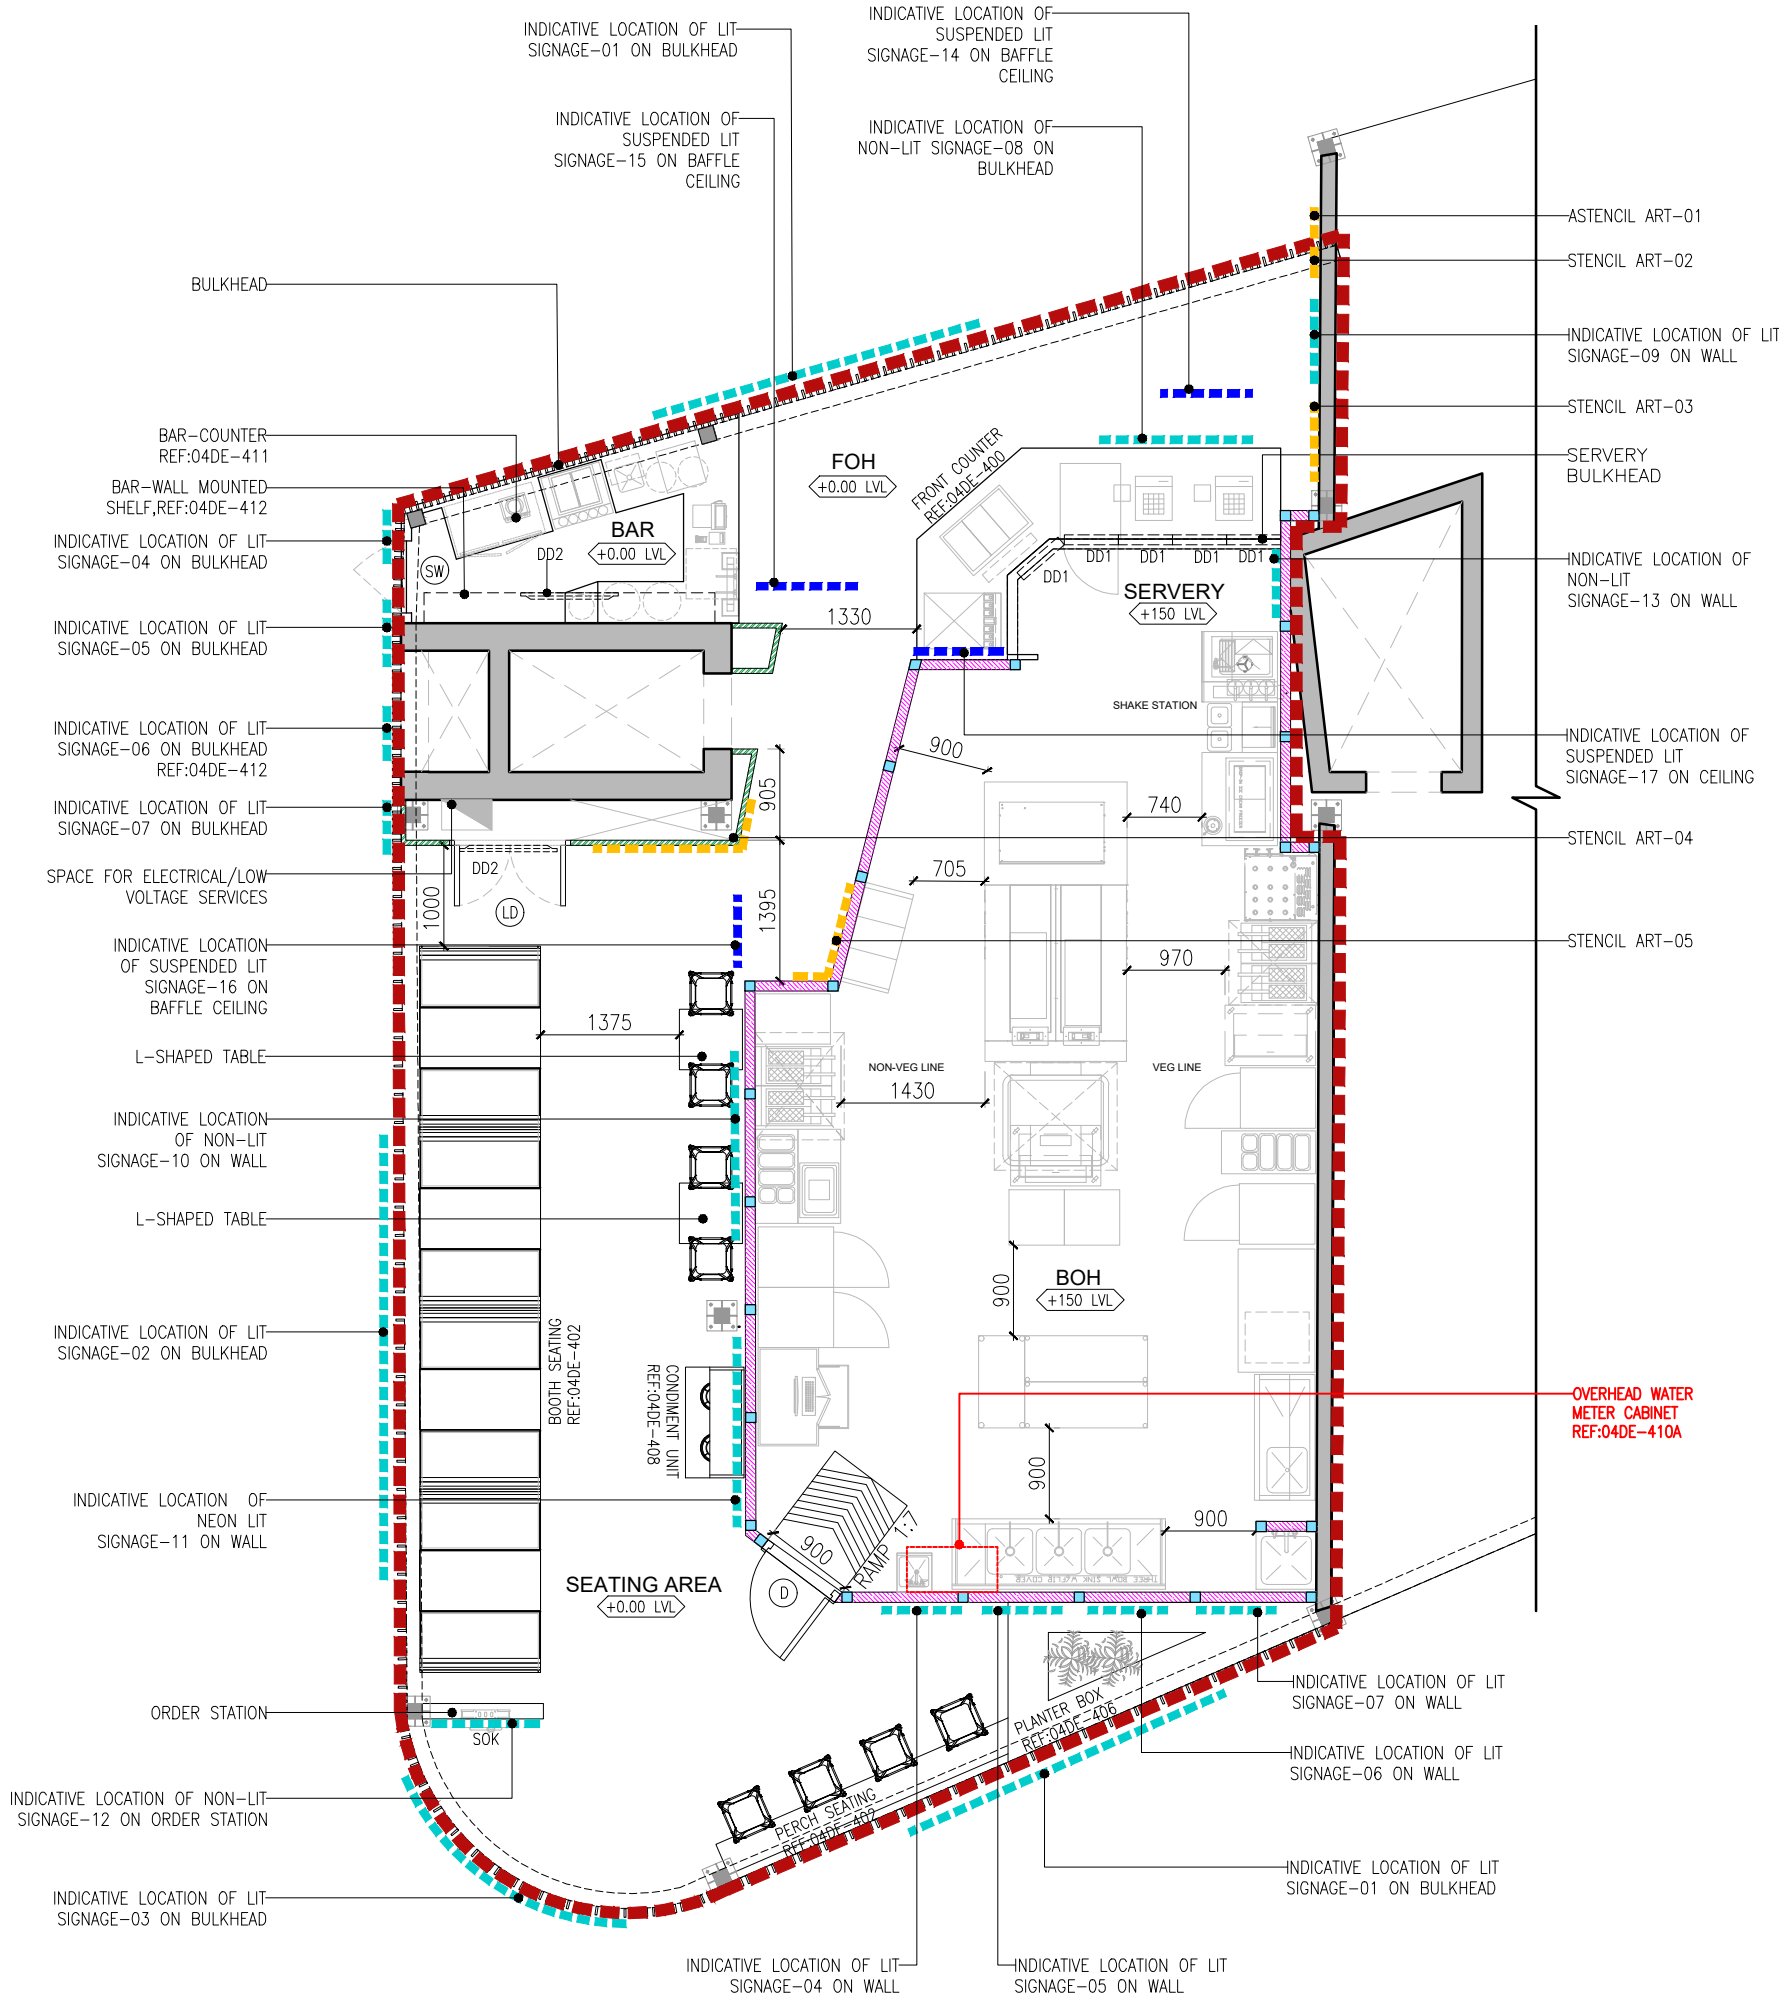

DOOR SCHEDULE					
CODE	TYPE	SIZE(MM)	LOCK	FIRE RATING	NOS.
LD	ISOLATOR LOUVRE DOOR	1200X2100	NO	1 HOUR	1
D	DOOR	900X2100	NO	1 HOUR	1
SW	SWING DOOR	815X850	NO	1 HOUR	1

WALL LEGEND			
#	PARTICULARS	SYMBOL	HEIGHTS (MM)
1	EXISTING WALL		-
2	PROPOSED 100MM THK MASONRY WALL		+3100
3	PROPOSED 50MM THK DRY PARTITION WALL		+3100
4	PROPOSED 100x100 MM CONCRETE FRAMING (M.20 MIX WITH NOMINAL REINFORCEMENTS)		+3100

DIGITAL DISPLAY			
CODE	SIZE	NAME	COUNT
DD1	43"	SUSPENDED DIGITAL DISPLAY(VERTICAL)	5
DD2	43"	WALL MOUNTED DIGITAL SCREEN (HORIZONTAL)	2

AREA STATEMENT		
#	DESCRIPTION	AREA/M ²
1	BAR+FOH+SEATING AREA	52.00
2	BOH	79.00
TOTAL		131.00

COVERS		
#	DESCRIPTION	NOS
1	BOOTH SEATING	16
2	PERCH SEATING	04
3	DINING SEATING	04
TOTAL		24

TO2 11.10.24	TENDER	HOD NM
TO1 08.06.24	TENDER	HOD NM
REV DATE	DESCRIPTION	DRN CHK



PROJECT
CARLSJR FF018
GMR INTERNATIONAL
AIRPORT LIMITED,
HYDERABAD


DRAWING TITLE
GENERAL ARRANGEMENT PLAN

SCALE 1:75 DATE 11.10.2024 DRAWN HOD A3 SHEET

STATUS
TENDER

ORG PROJECT NO DRAWING TYPE NUMBER REV
TFS 0000 02GA 100 T02

NOTE:REFER MEP DRAWING
FOR DETAIL DESIGN

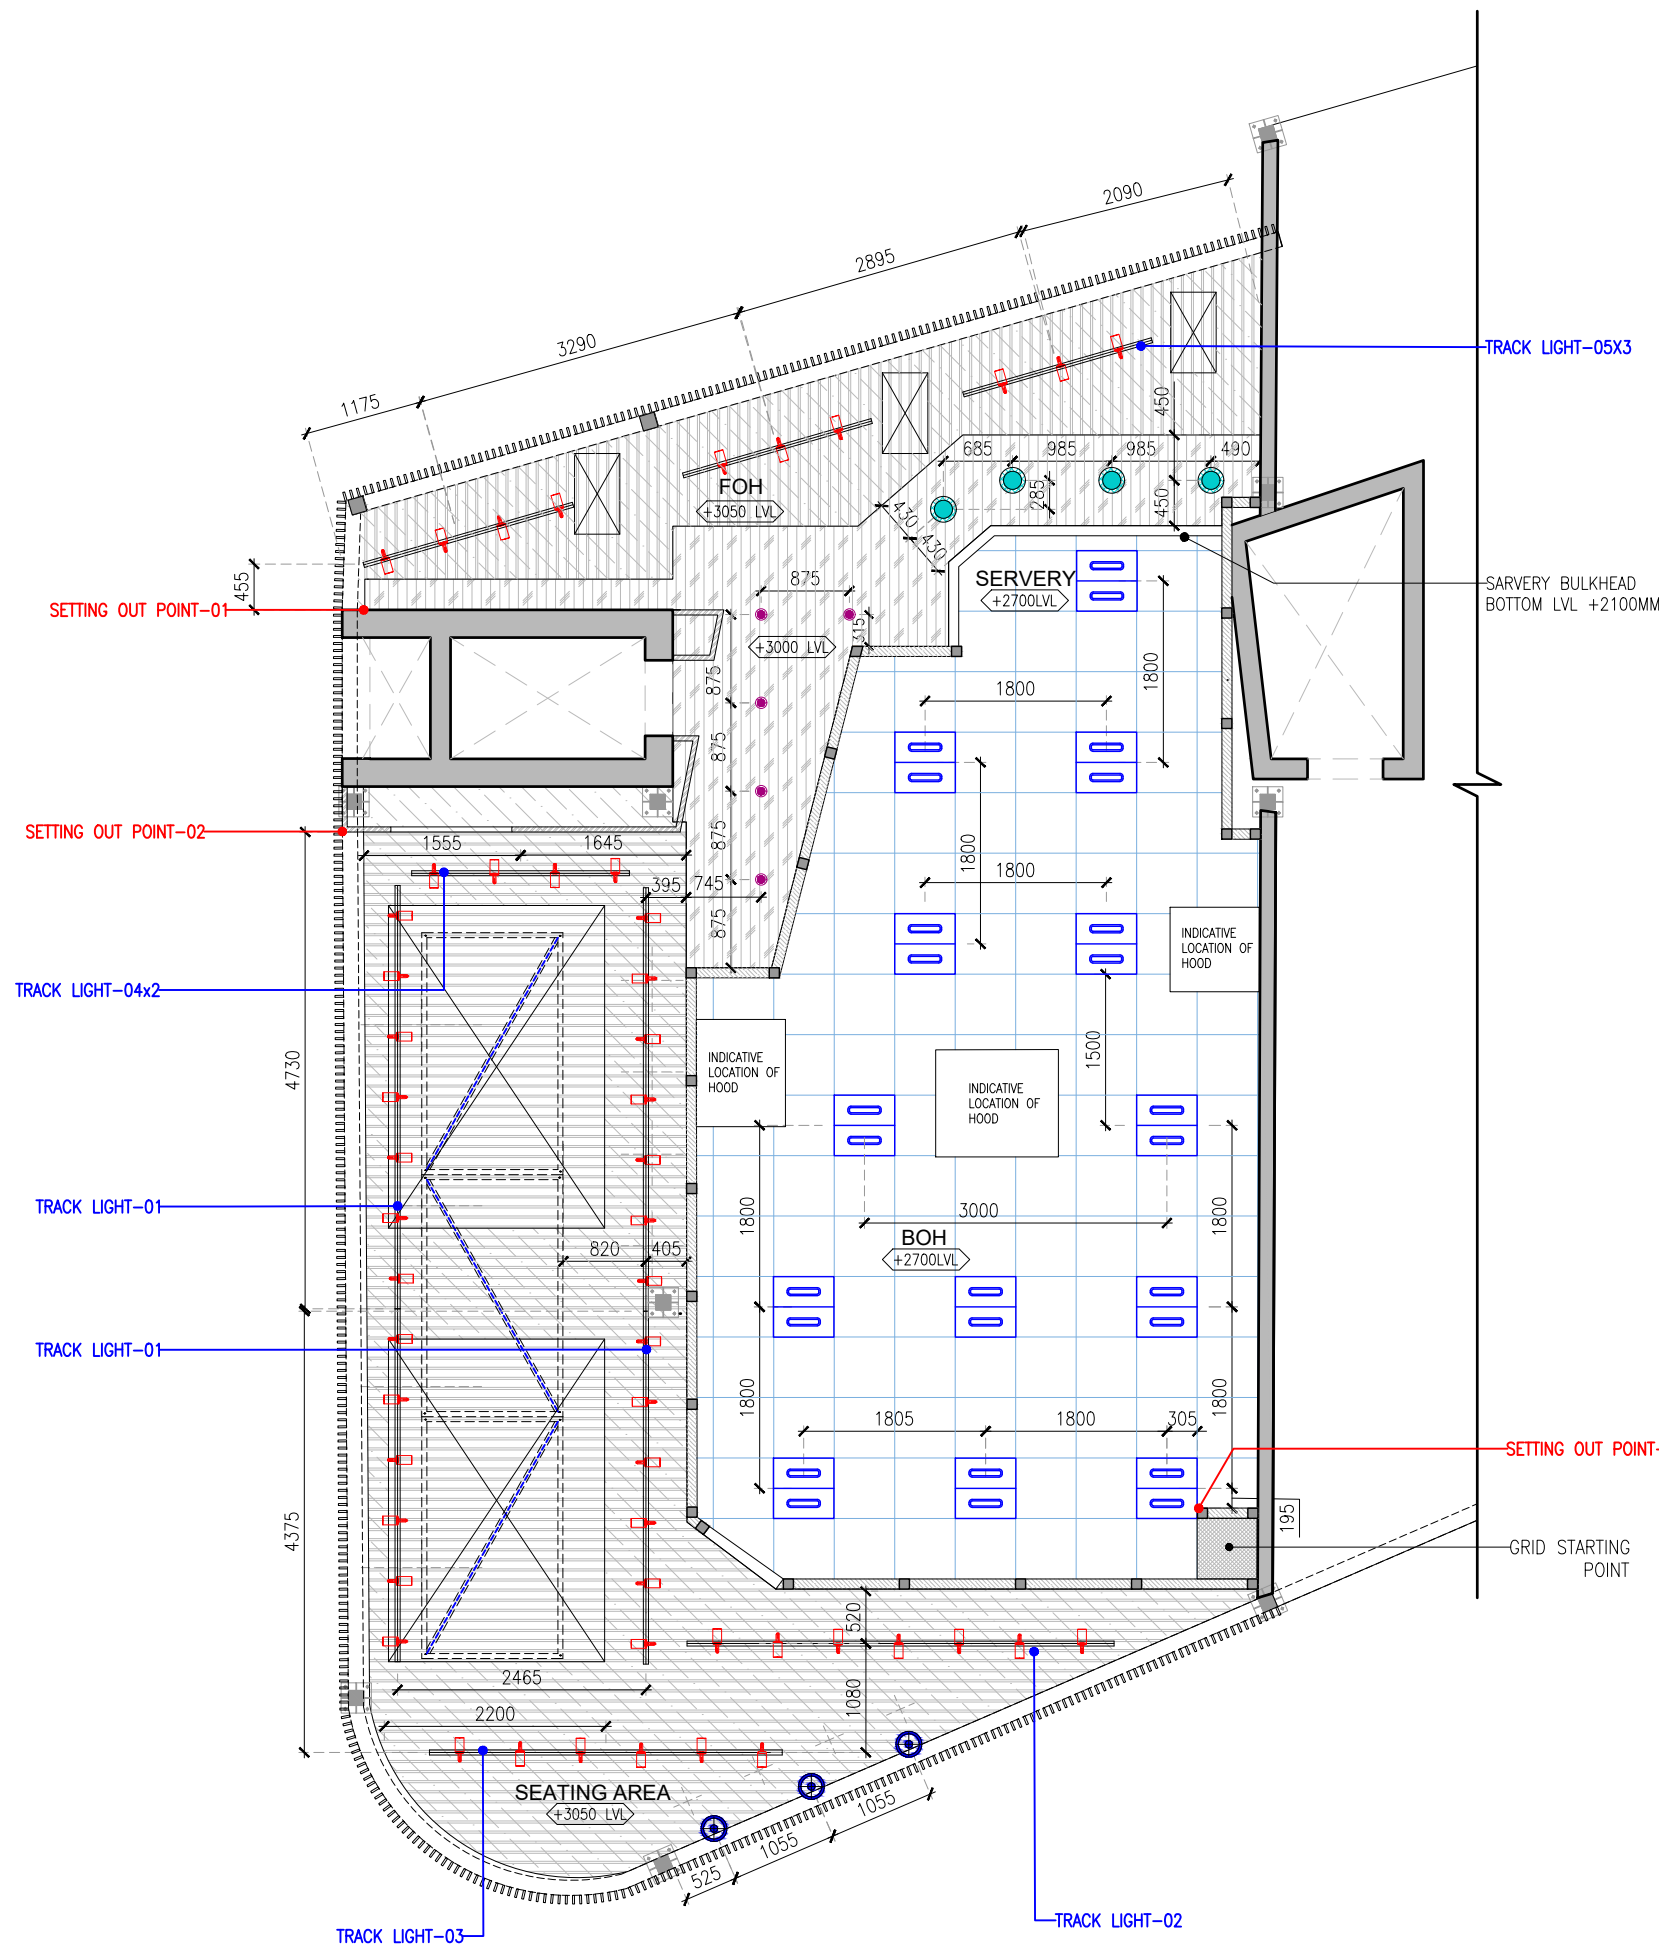

LIGHTING LEGEND			
CODE	SYMBOL	TYPE	NOS
LT01		CEILING LAMP TEMP:2700K	4
LT02		PENDANT LIGHT TEMP:3000K	3
LT03		DOWNLIGHT LIGHT TEMP:3000K	5
LT04		600X600MM LED PANEL LIGHT TEMP:3000K	13
LT05		TRACK:01 LENGTH:7.74 M FINISH:BLACK	2
		TRACK:02 LENGTH:4.2 M FINISH:BLACK	1
		TRACK:03 LENGTH:3.5 M FINISH:BLACK	1
		TRACK:04 LENGTH:2.9 M FINISH:BLACK	2
		TRACK:05 LENGTH:1.9 M FINISH:BLACK	2
		LIGHT TEMP:3000K FINISH:BLACK	53
LT06		LED STRIP LIGHT TEMP:3000K	8 Mtr

REV	DATE	DESCRIPTION	DRN	CHK
T02	11.10.24	TENDER		HOD NM
T01	29.08.24	TENDER		HOD NM



PROJECT
CARLSJR FF018
GMR INTERNATIONAL
AIRPORT LIMITED,
HYDERABAD


DRAWING TITLE
LIGHTING LAYOUT & SCHEDULE

SCALE 1:75 DATE 11.10.2024 DRAWN HOD A3 SHEET

STATUS
TENDER

ORG	PROJECT NO	DRAWING TYPE	NUMBER	REV
TFS	0000	02GA	104B	T02

01 LIGHTING LAYOUT & SCHEDULE
02GA-104B 1:75

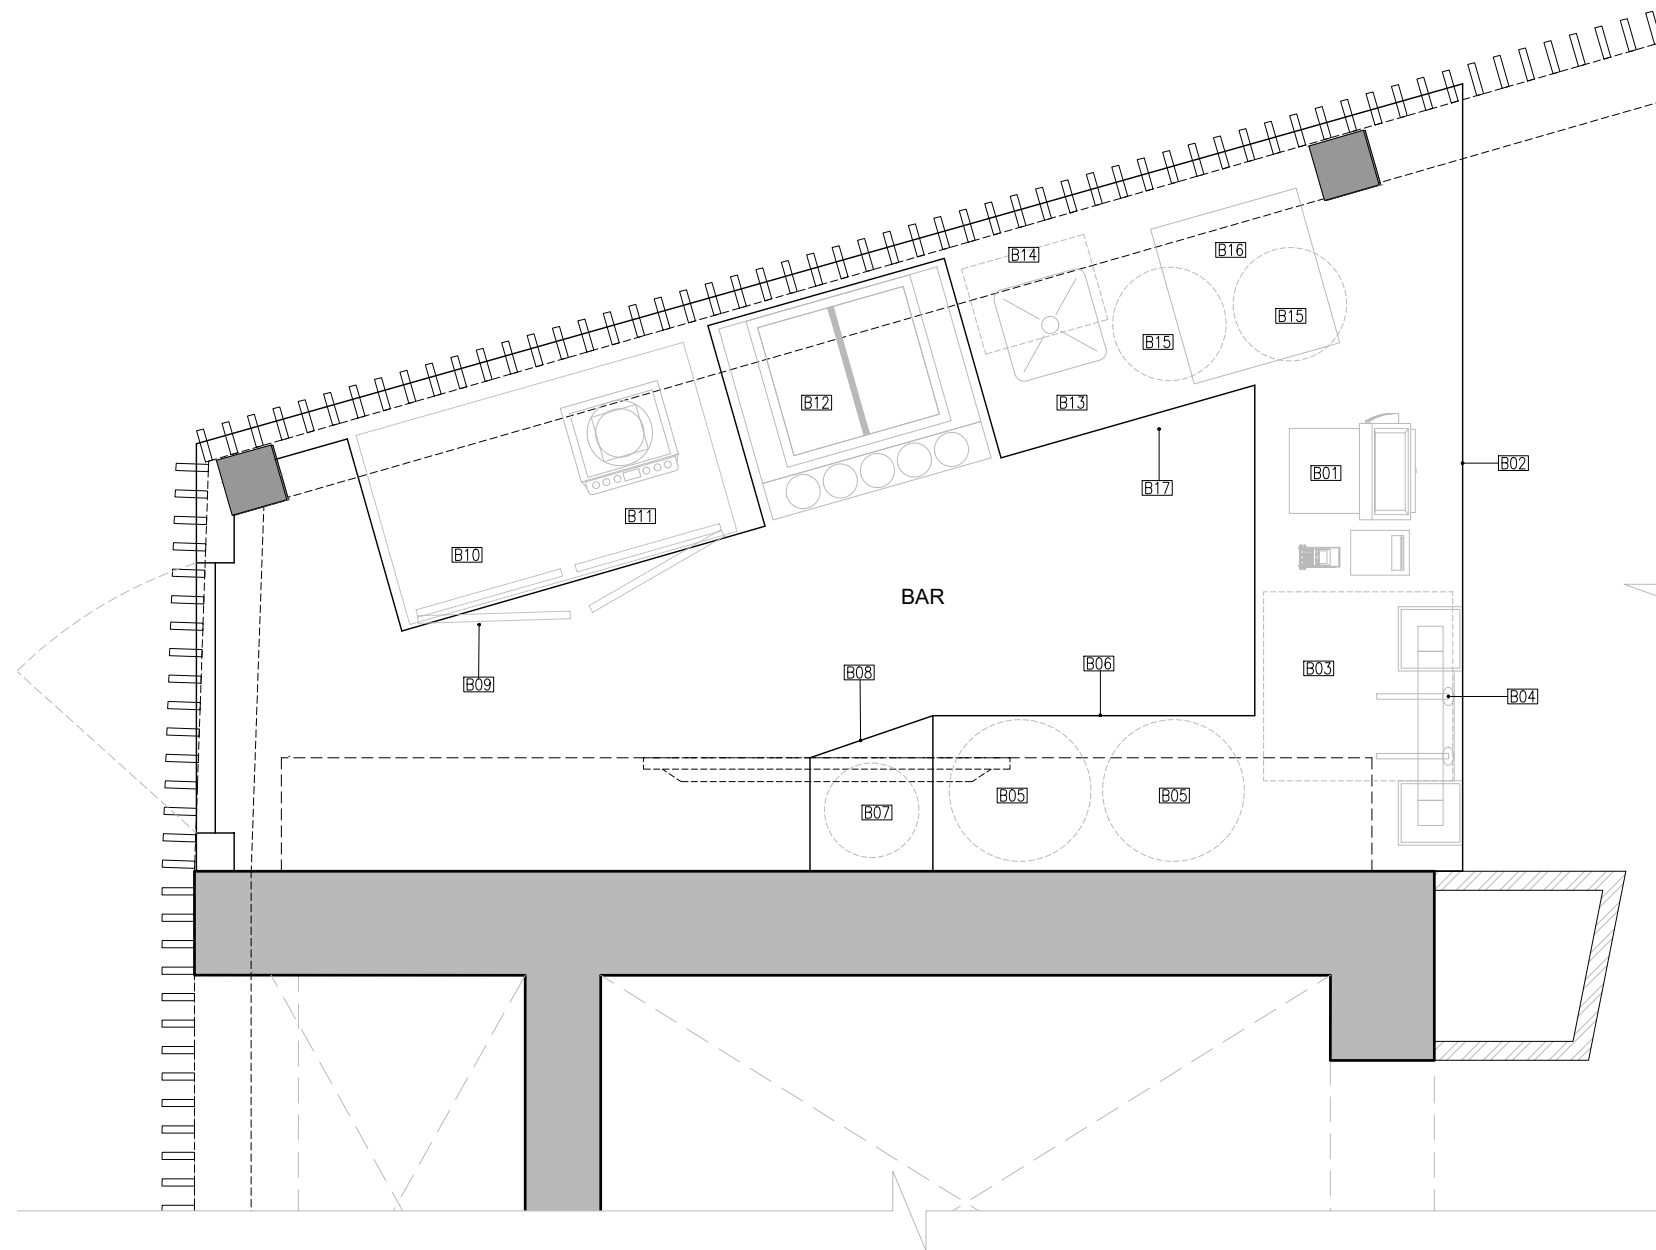

BAR-EQUIPMENT LEGEND		
CODE	DESCRIPTION	QTY PER UNIT
B01	POS	1
B02	POS COUNTER WITH STORAGE BELOW (CARPENTRY)	1
B03	UNDERNEATH BEER CHILLING MACHINE	1
B04	BEER TOWER 2 TAPS	1
B05	BEER BARREL KEG (UNDERNEAH)	2
B06	COUNTER WITH PROVISION BELOW FOR BEER KEG & BEER CHILLING MACHINE(CARPENTRY)	1
B07	CO2 CYLINDER	1
B08	BOXING WITH DOOR IN FRONT FOR CO2 CYLINDER	1
B09	COUNTER WITH PROVISION OF 2DOOR CHILLER BELOW	1
B10	2 DOOR UNDER COUNTER BACK CHILLER	1
B11	BLENDER M/C2 SPEED	1
B12	COCKTAIL STATION WITH 1 U/S & 1 NO , ICE BOX WITH SPEED RAIL	1
B13	SUNK IN SINK (BOWL SIZE-350x350x250 Deep)	1
B14	MINI WATER PUMP	1
B15	UNDERNEATH 20 Ltrs. BOTTLE JARS FOR DRAIN & PLAIN WATER	2
B16	TABLE TOP ICE CUBE MACHINE	1
B17	COUNTER WITH PROVISION OF 2 Nos JARS BELOW (CARPENTRY)	1

01 EQUIPMENT LAYOUT
02GA-106 1:75

REV	DATE	DESCRIPTION	HOD	CHK
T02	11.10.24	TENDER		NM
T01	08.06.24	TENDER		NM



PROJECT
CARLSJR FF018
GMR INTERNATIONAL
AIRPORT LIMITED,
HYDERABAD


DRAWING TITLE
EQUIPMENT LAYOUT

SCALE 1:75 DATE 11.10.2024 DRAWN HOD A3 SHEET


STATUS
TENDER

ORG	PROJECT NO	DRAWING TYPE	NUMBER	REV
TFS	0000	02GA	106	T02

LOCATION AND DIMENSIONS OF AIRPORT GRILLES TO BE COORDINATED WITH SITE CONDITIONS

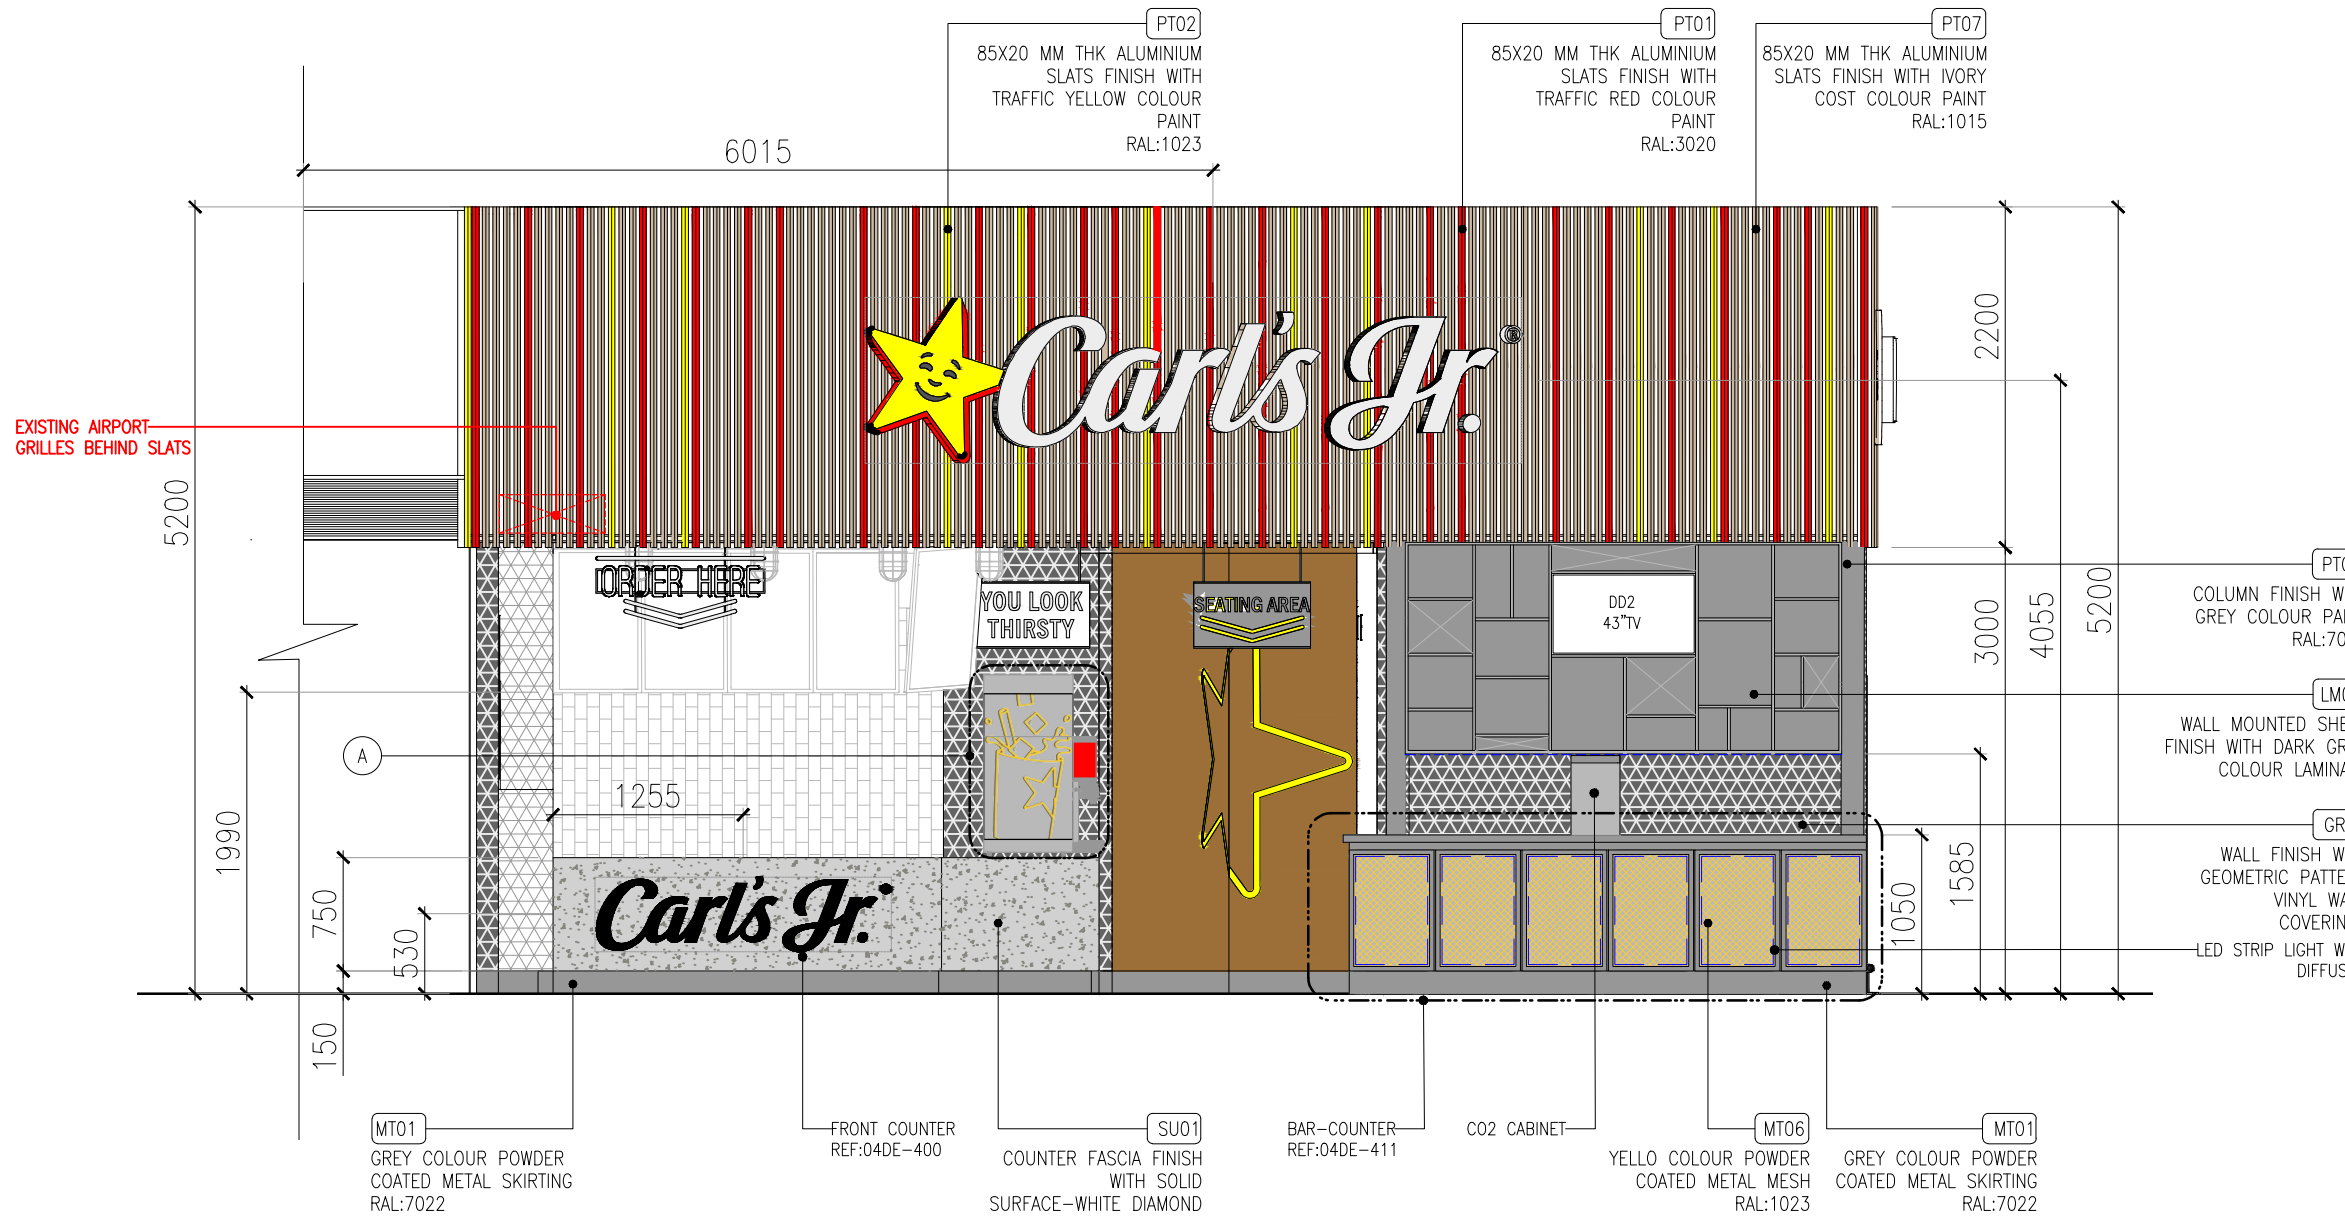

VINYL STICKER AS PER BRAND

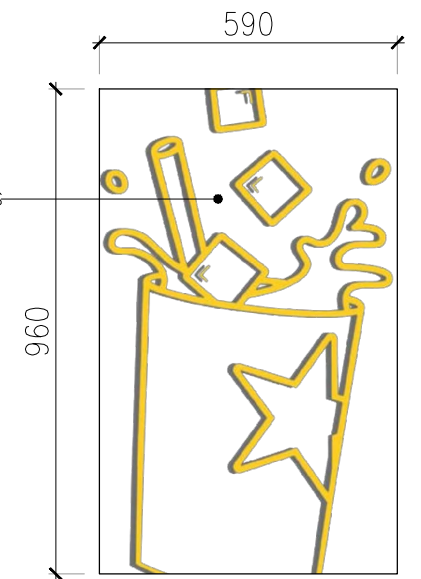

DETAIL-A(SCALE 1:15)

01 ELEVATION-01
OSL-300 1:50

T02	11.10.24	TENDER	HOD	NM
T01	25.05.24	TENDER	HOD	NM
REV	DATE	DESCRIPTION	DRN	CHK




PROJECT
CARLSJR FF018
GMR INTERNATIONAL
AIRPORT LIMITED,
HYDERABAD

DRAWING TITLE
ELEVATION-01


SCALE AS MENTIONED DATE 11.10.2024 DRAWN HOD A3 SHEET

STATUS
TENDER


ORG	PROJECT NO	DRAWING TYPE	NUMBER	REV
TFS	0000	03IL	300	T02

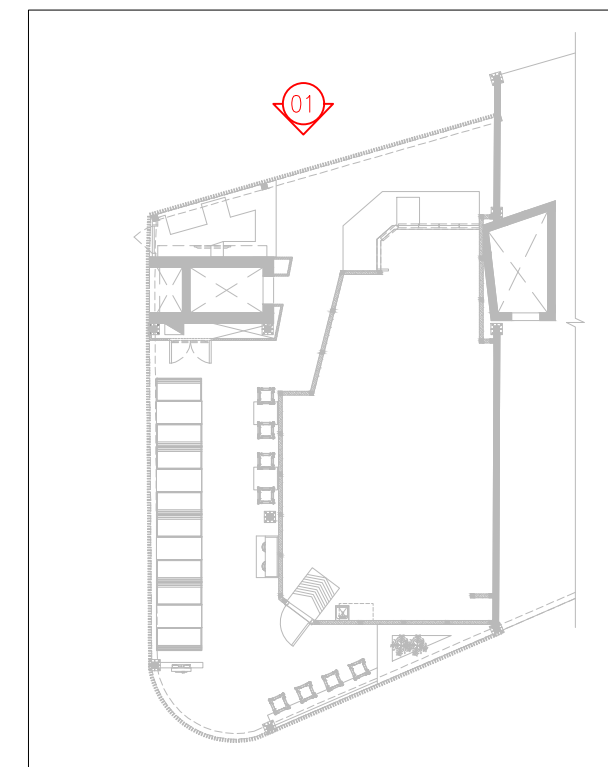


KEYPLAN

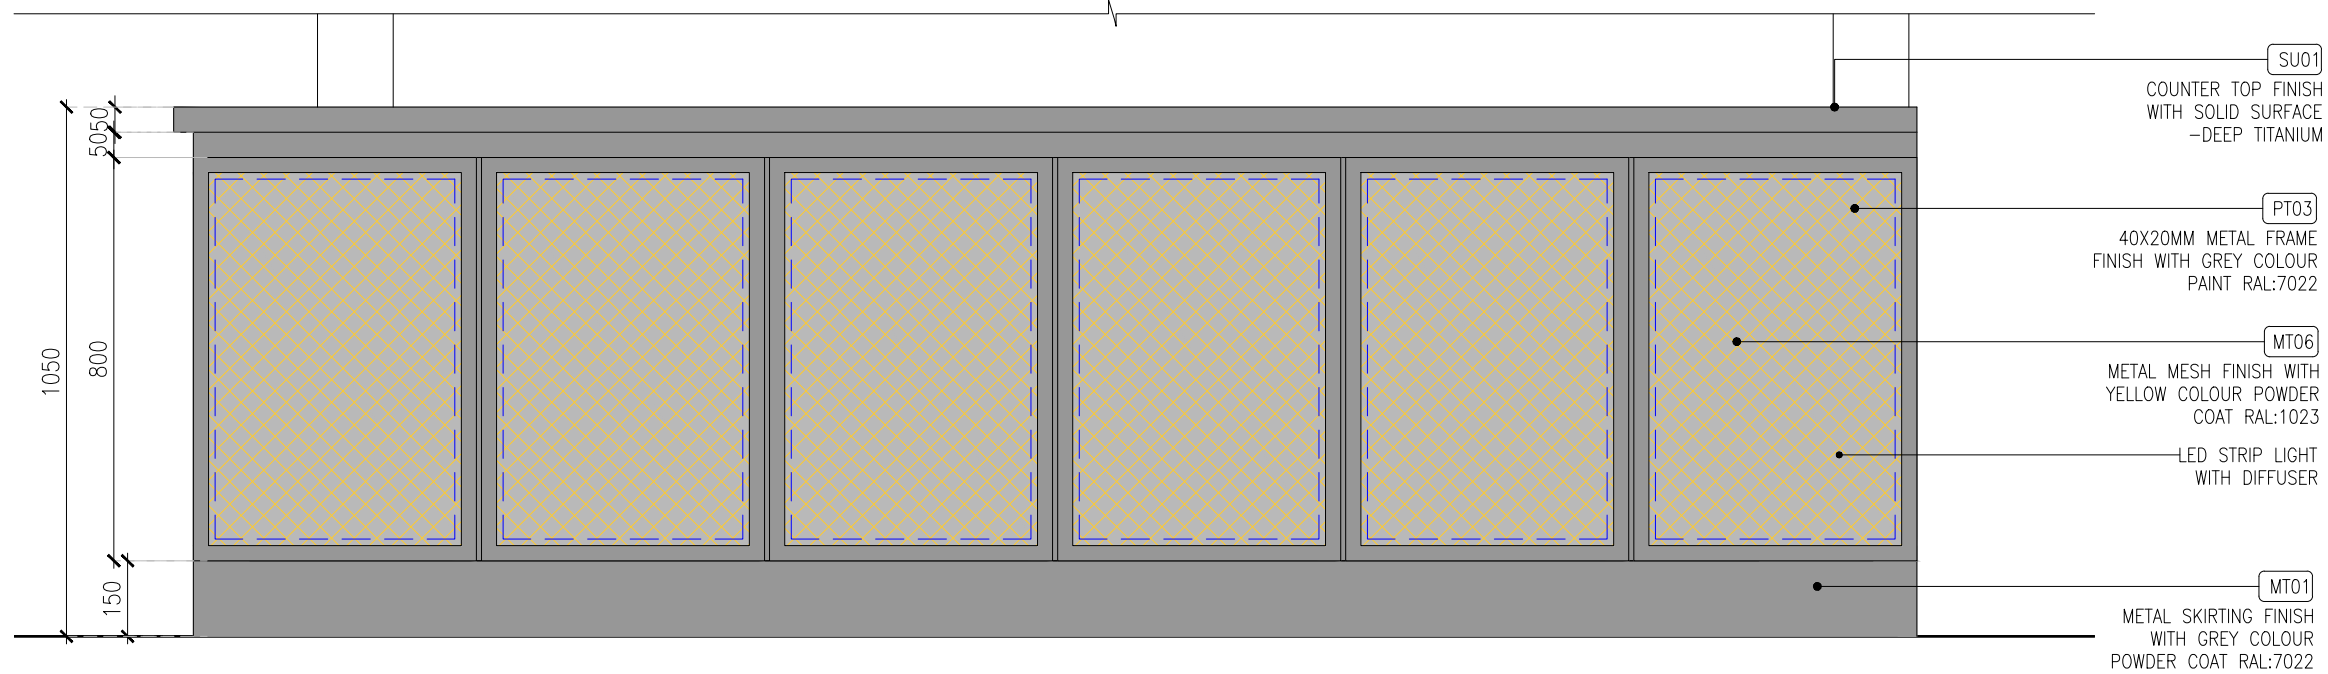

01 ELEVATION -01
04DE-411A 1:15

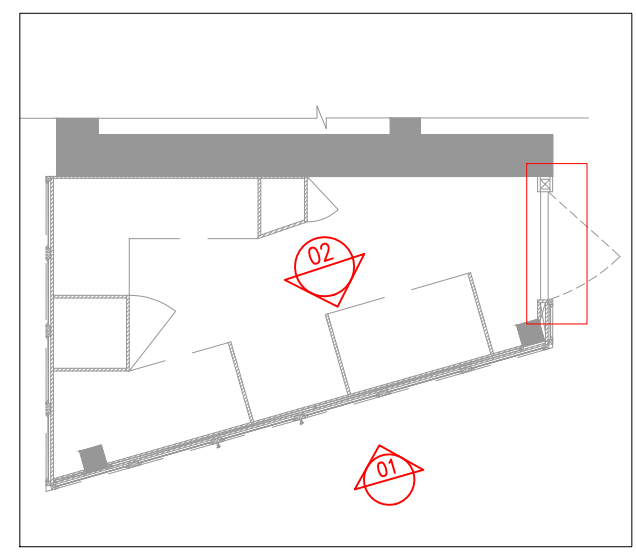

KEYPLAN

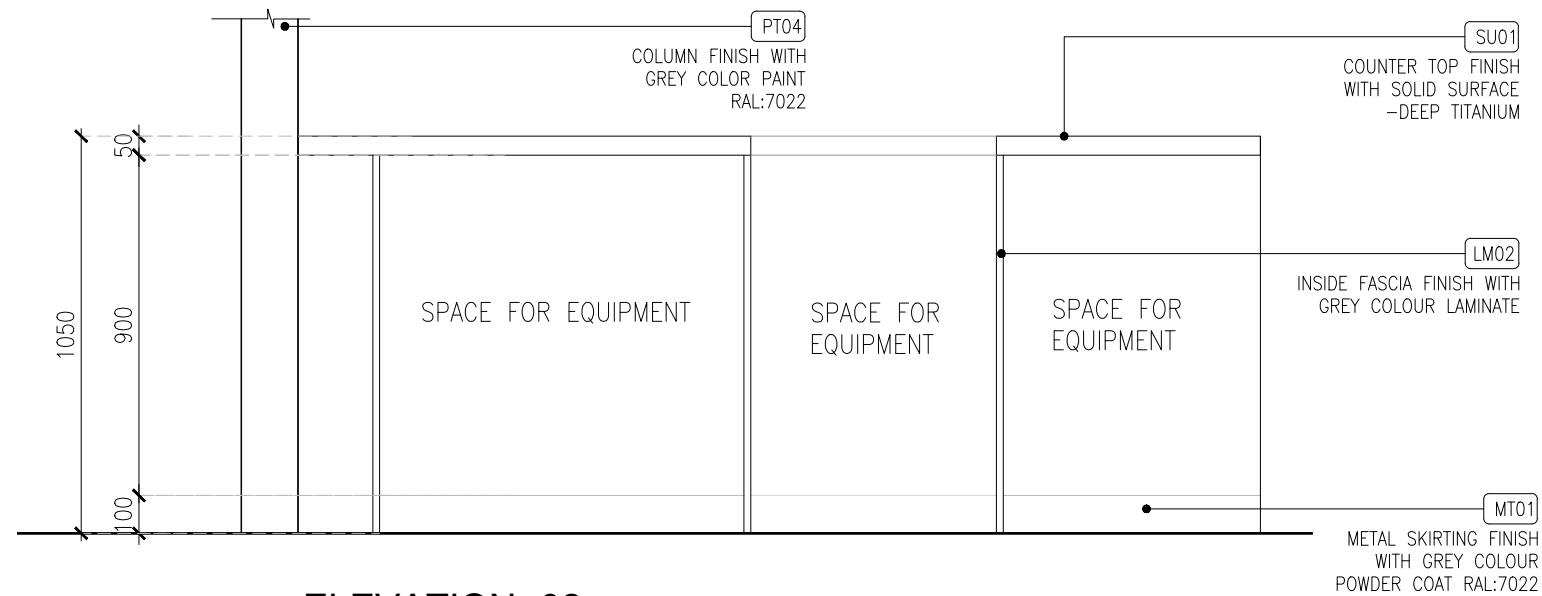

02 ELEVATION -02
04DE-411A 1:15

REV	DATE	DESCRIPTION	HOD	NM
T02	18.09.24	TENDER		
DRN			CHK	




PROJECT
CARLSJR FF018
GMR INTERNATIONAL
AIRPORT LIMITED,
HYDERABAD

DRAWING TITLE
J13-BAR COUNTER DETAIL-PART:B
& J15-SWING DOOR DETAIL

SCALE AS MENTIONED DATE 11.10.2024 DRAWN HOD A3 SHEET

STATUS
TENDER


ORG	PROJECT NO	DRAWING TYPE	NUMBER	REV
TFS	0000	04DE	411A	T02

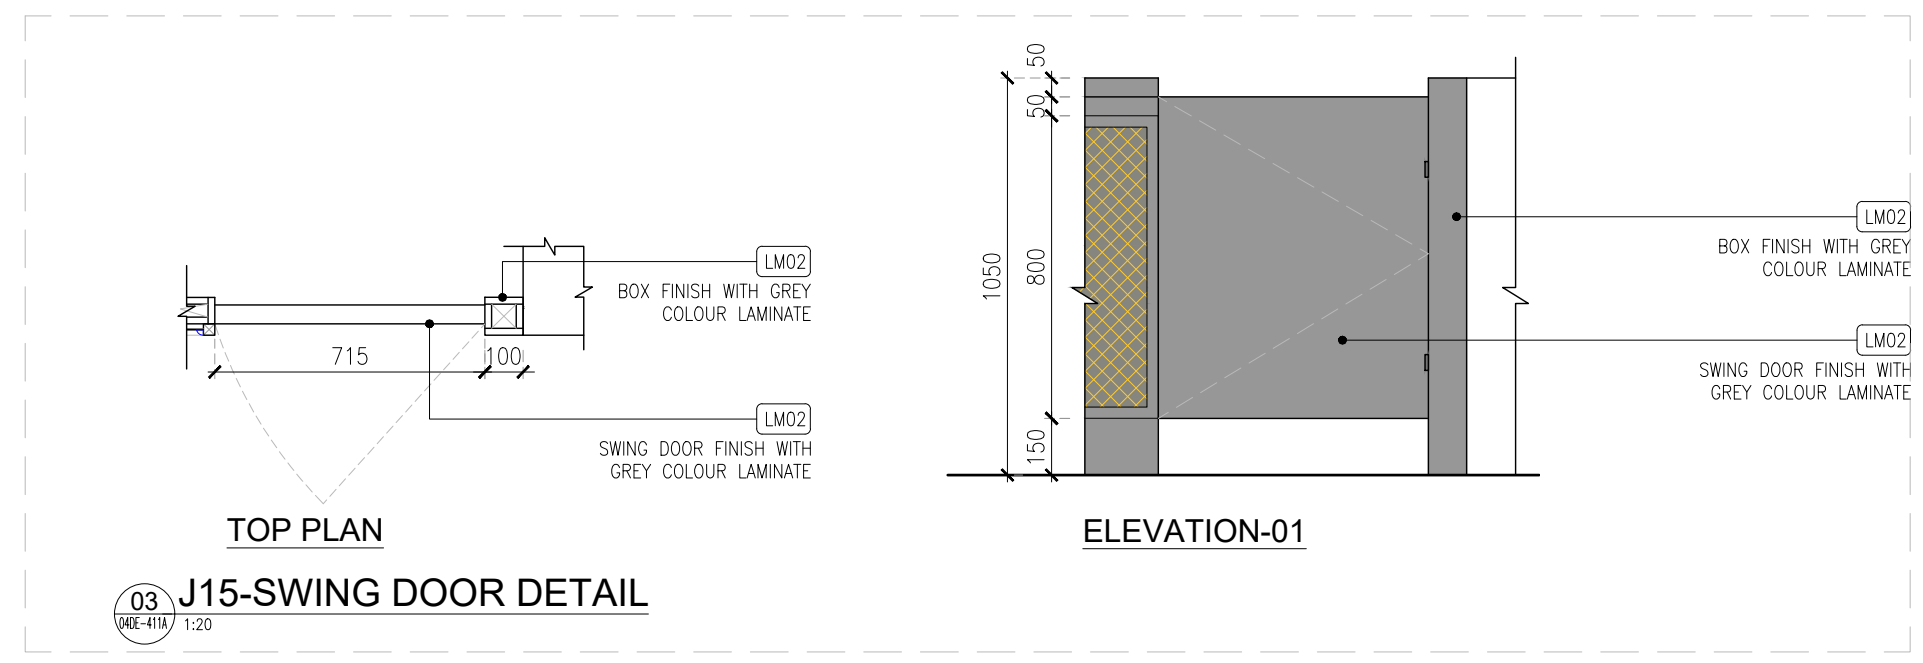


TOP PLAN

ELEVATION-01


03 J15-SWING DOOR DETAIL
04DE-411A 1:20

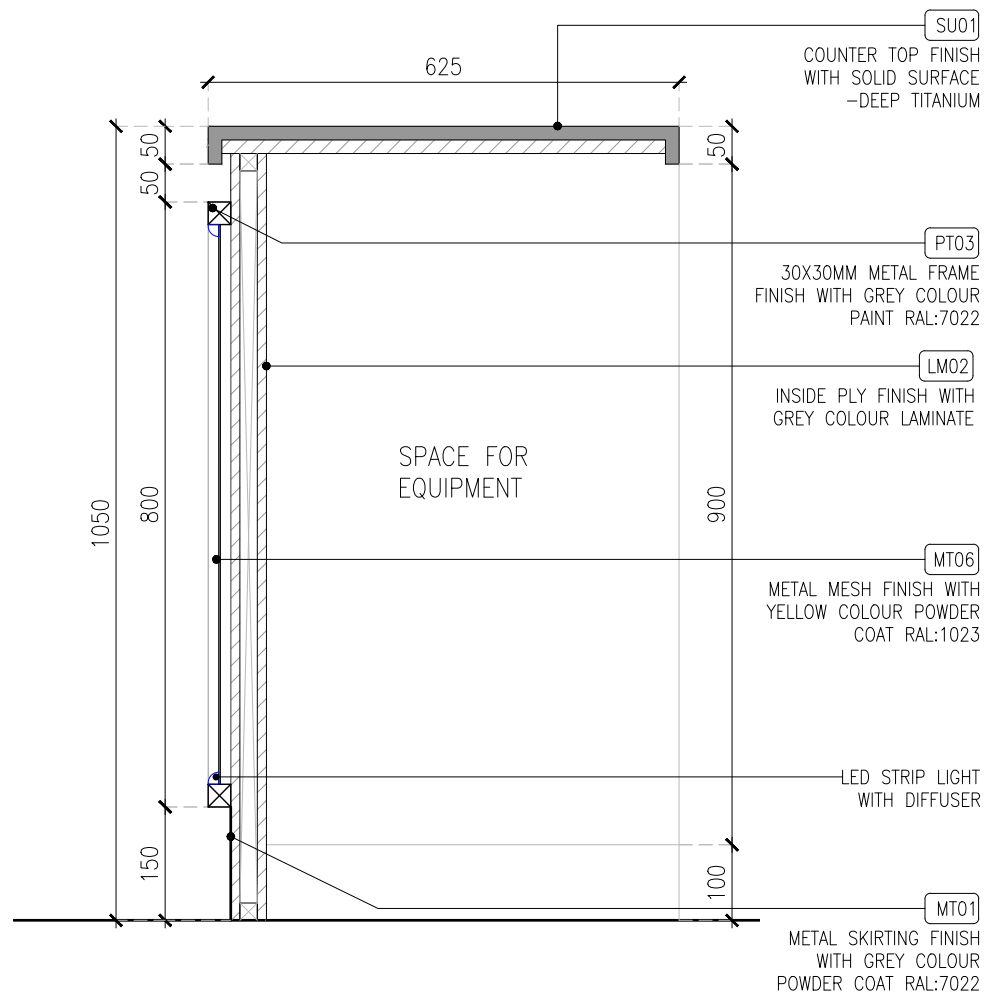


01 SECTION -01
04DE-411B 1:10

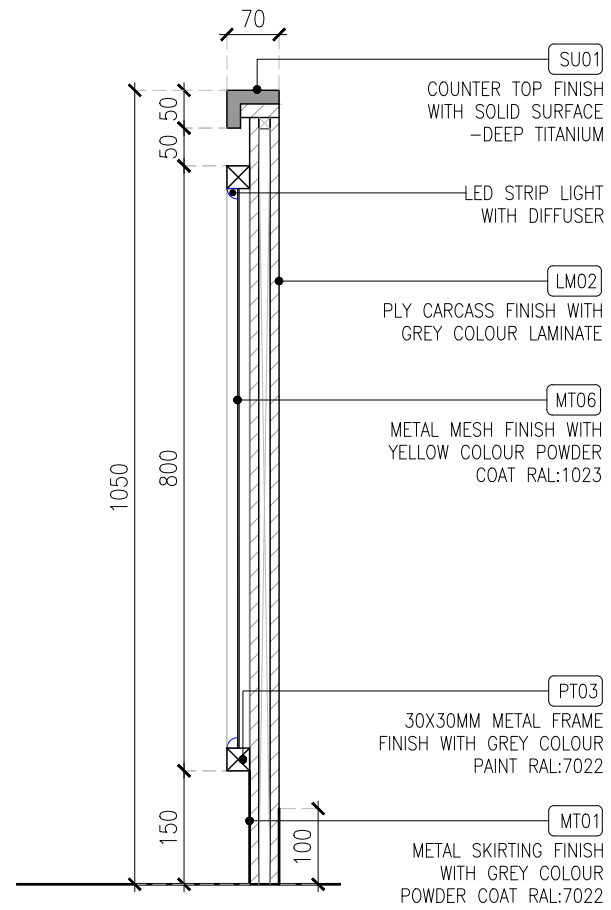


02 SECTION -02
04DE-411B 1:10

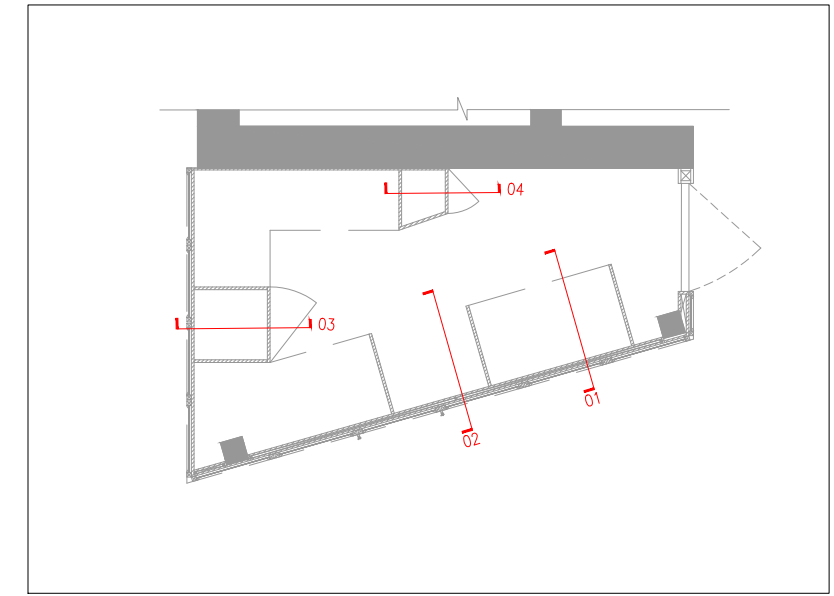

KEYPLAN

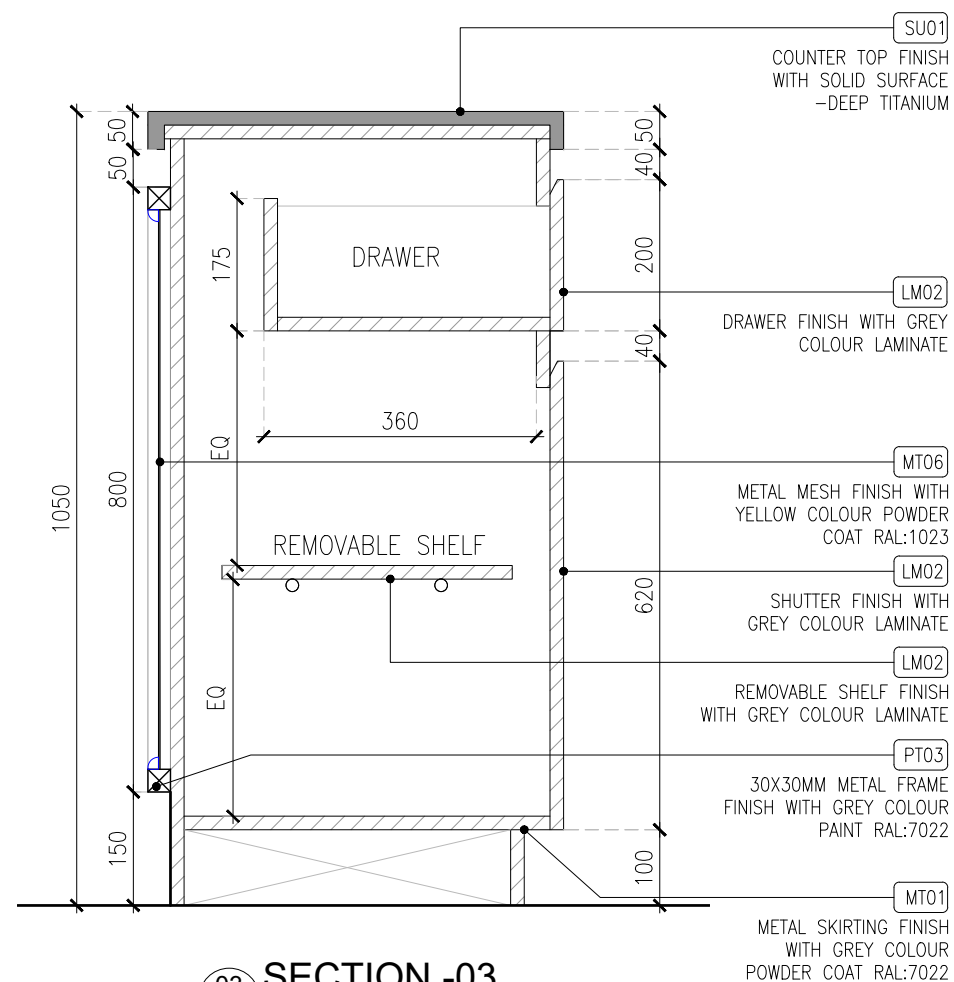

03 SECTION -03
04DE-411B 1:10

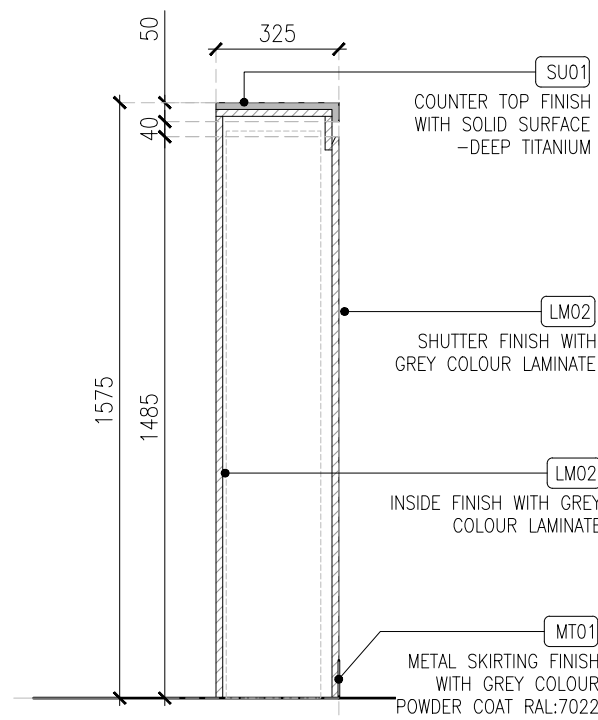

04 SECTION -04
04DE-411B 1:10

T02	18.09.24	TENDER	HOD	NM
REV	DATE	DESCRIPTION	DRN	CHK




PROJECT
CARLSJR FF018
GMR INTERNATIONAL
AIRPORT LIMITED,
HYDERABAD

DRAWING TITLE
J13-BAR COUNTER DETAIL-PART:C

SCALE 1:10 DATE 11.10.2024 DRAWN HOD A3 SHEET

STATUS
TENDER


ORG	PROJECT NO	DRAWING TYPE	NUMBER	REV
TFS	0000	04DE	411B	T02

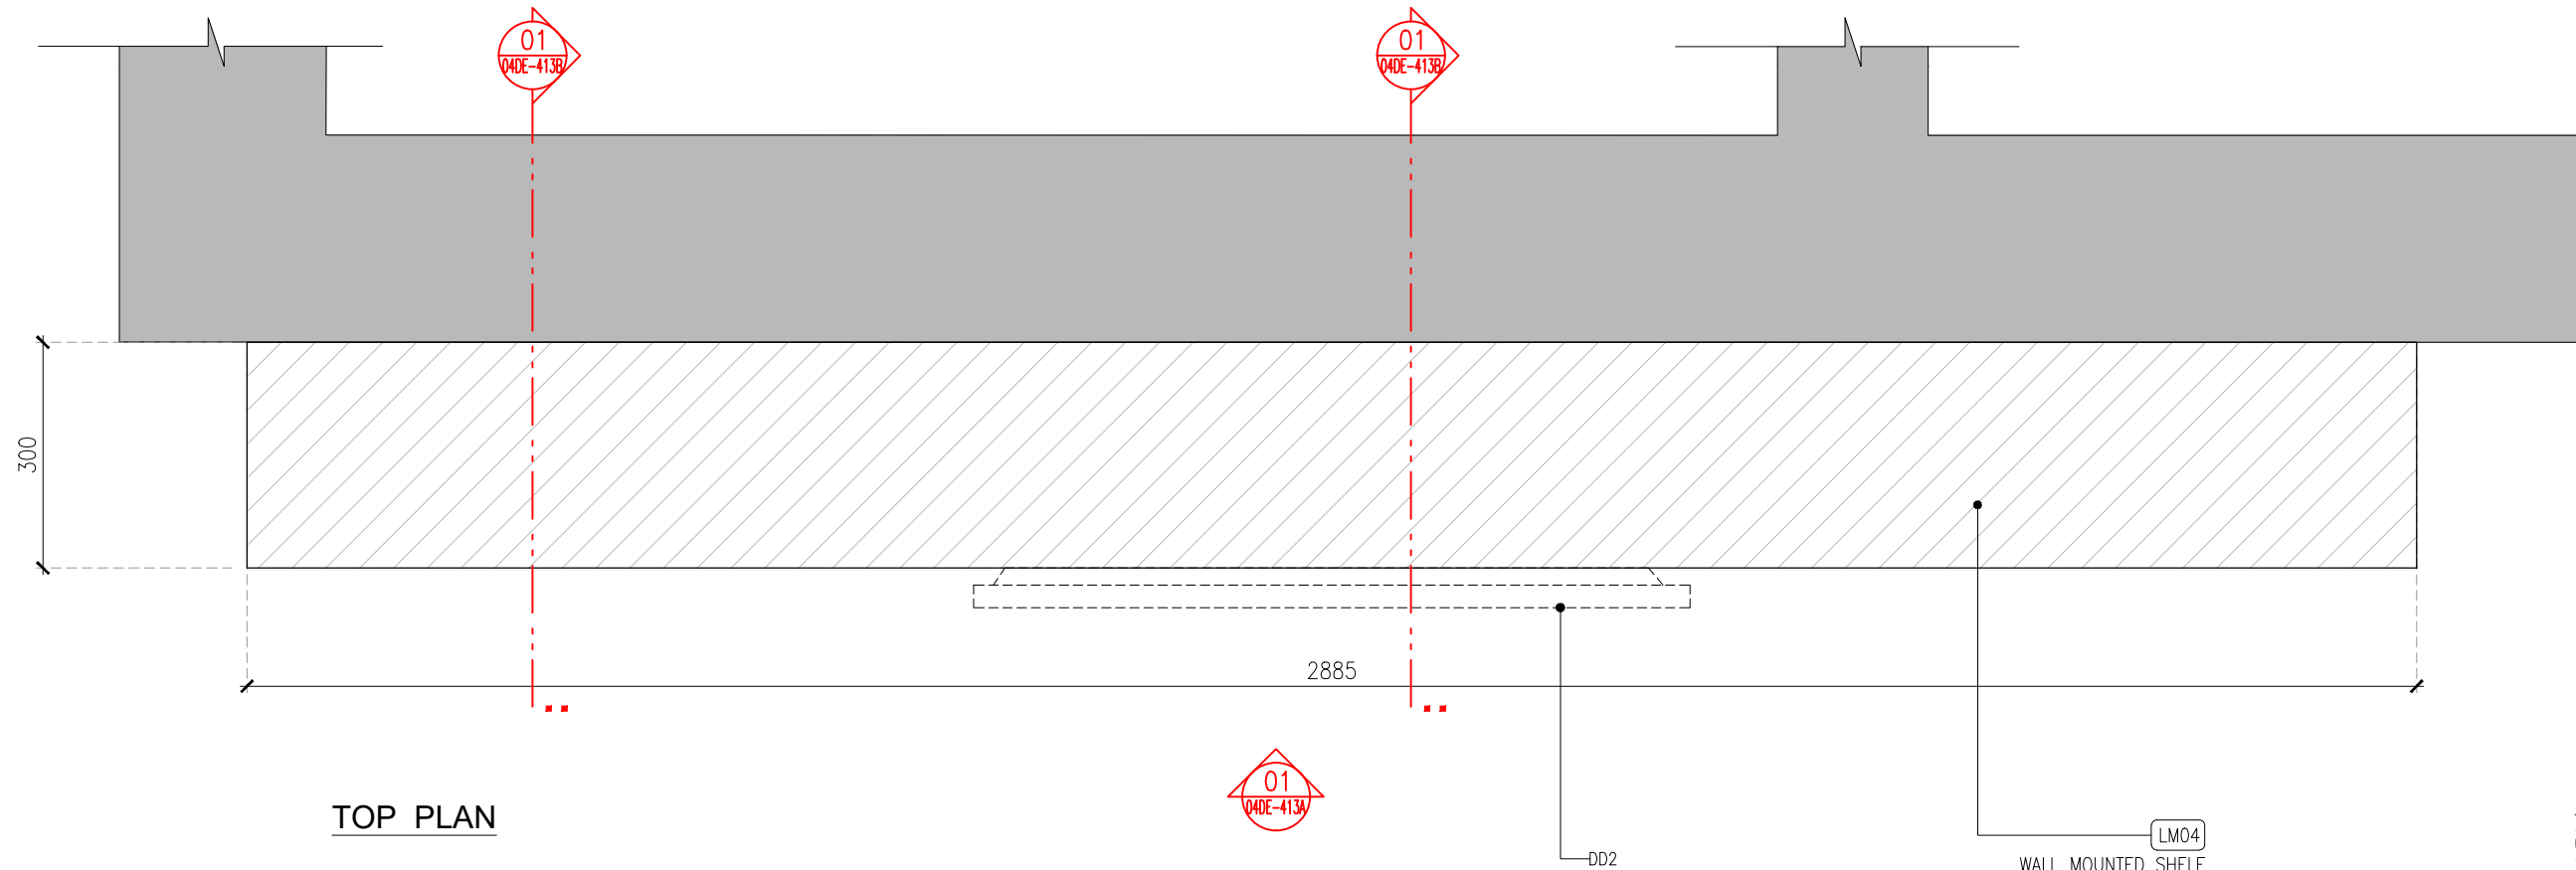

TOP PLAN

LM04
WALL MOUNTED SHELF
FINISH WITH DARK GREY
COLOUR LAMINATE

01 J14-BAR-WALL MOUNTED SHELF DETAIL-PART:A
04DE-412 1:10

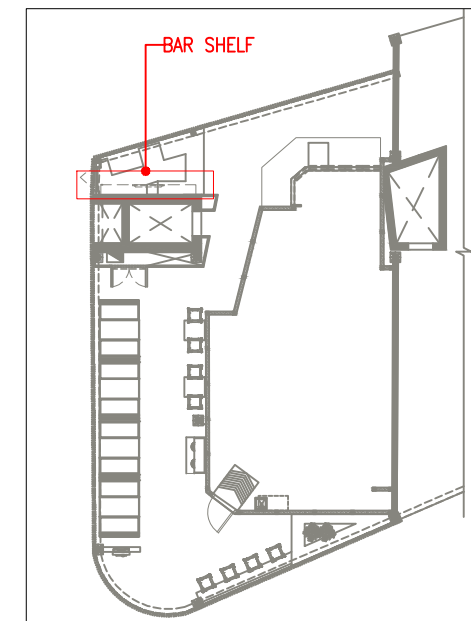

KEYPLAN

T02	11.10.24	TENDER	HOD	NM
REV	DATE	DESCRIPTION	DRN	CHK




PROJECT
CARLSJR FF018
GMR INTERNATIONAL
AIRPORT LIMITED,
HYDERABAD

DRAWING TITLE
J14-BAR-WALL MOUNTED SHELF
DETAIL-PART:A

SCALE 1:10 DATE 11.10.2024 DRAWN HOD A3 SHEET

STATUS
TENDER


ORG	PROJECT NO	DRAWING TYPE	NUMBER	REV
TFS	0000	04DE	412	T02

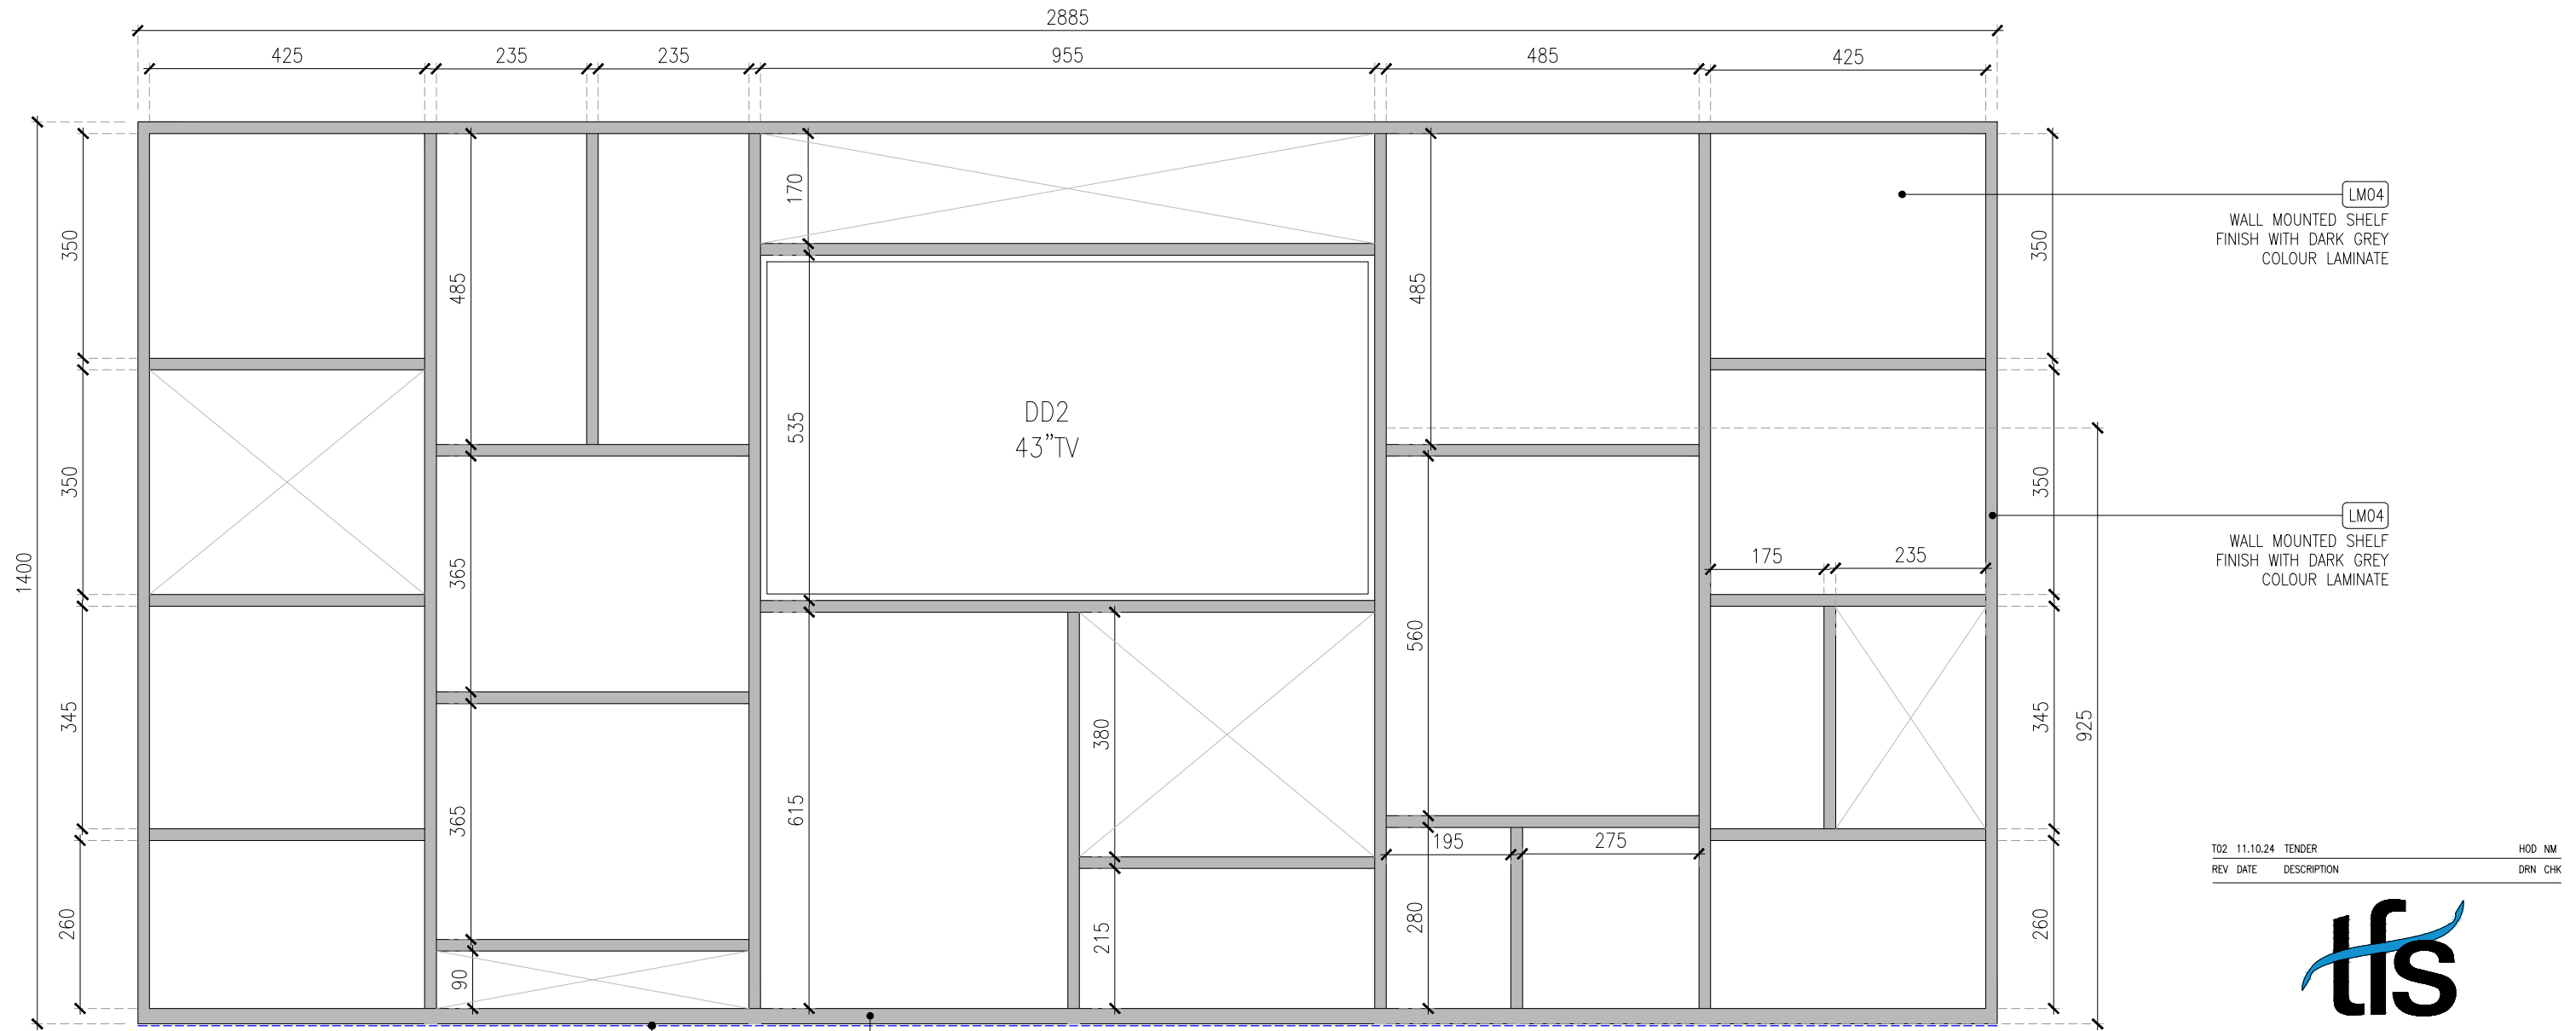

01 ELAVTION-01
04DE-412A 1:10

LED STRIP LIGHT WITH DIFFUSER

LM04 WALL MOUNTED SHELF FINISH WITH DARK GREY COLOUR LAMINATE

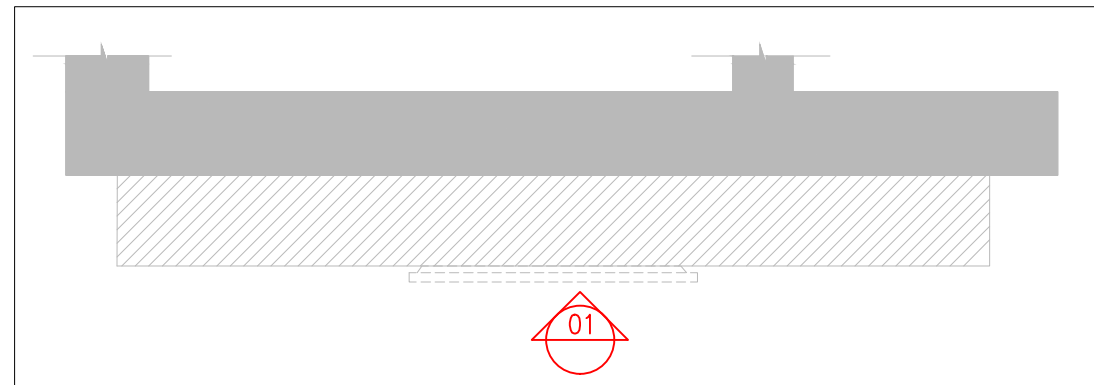

KEYPLAN

T02	11.10.24	TENDER	HOD	NM
REV	DATE	DESCRIPTION	DRN	CHK





PROJECT
CARLSJR FF018
GMR INTERNATIONAL
AIRPORT LIMITED,
HYDERABAD

DRAWING TITLE
J14-BAR-WALL MOUNTED SHELF
DETAIL-PART:B

SCALE 1:10 DATE 11.10.2024 DRAWN HOD A3 SHEET


STATUS
TENDER

ORG	PROJECT NO	DRAWING TYPE	NUMBER	REV
TFS	0000	04DE	412A	T02

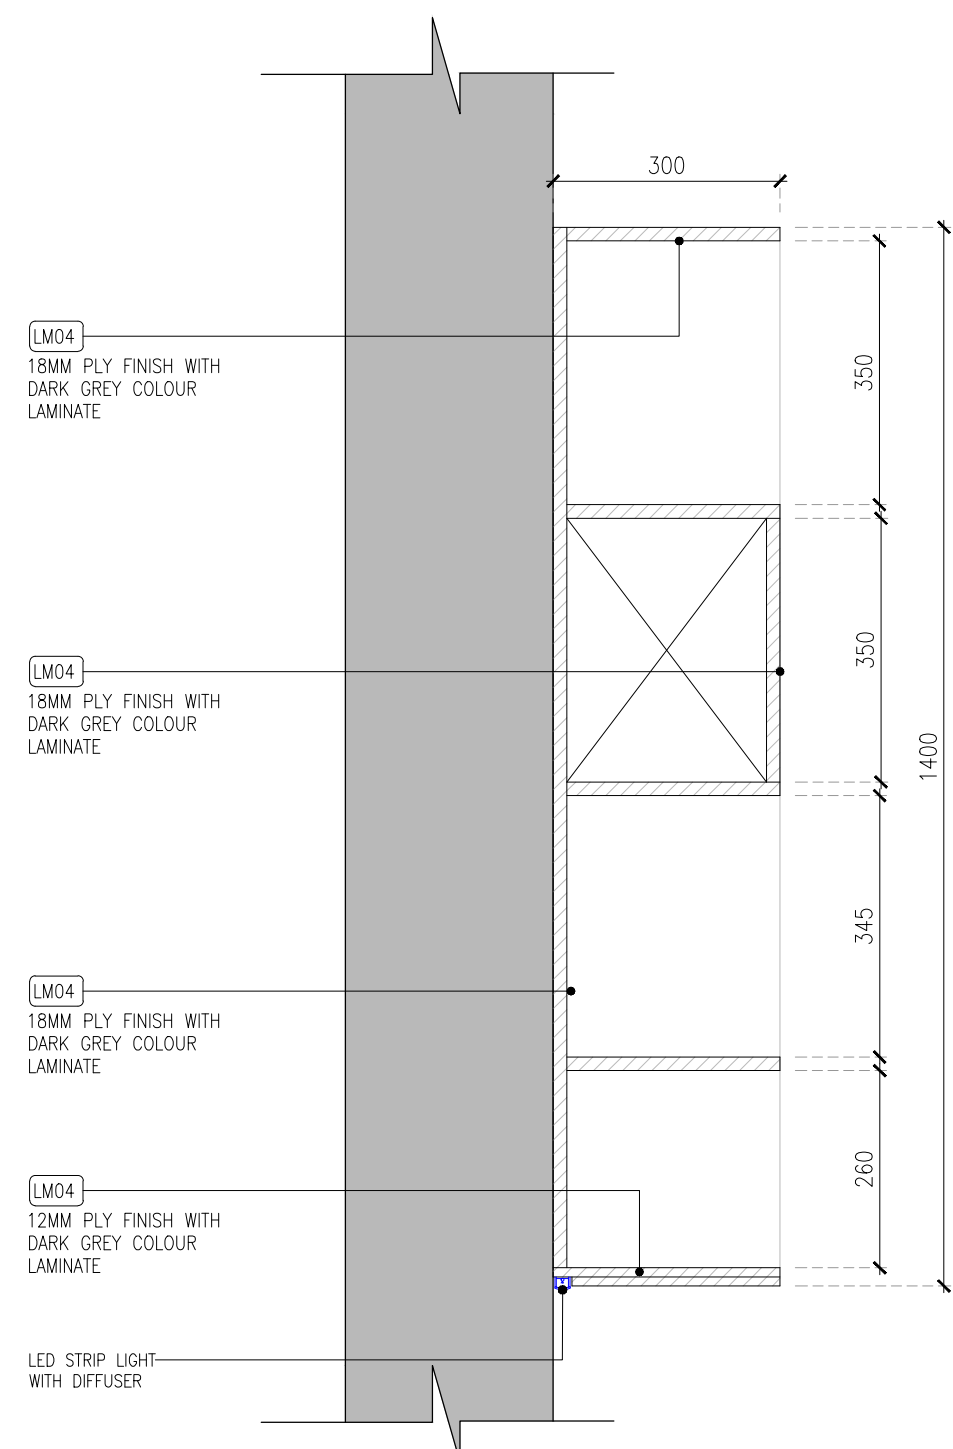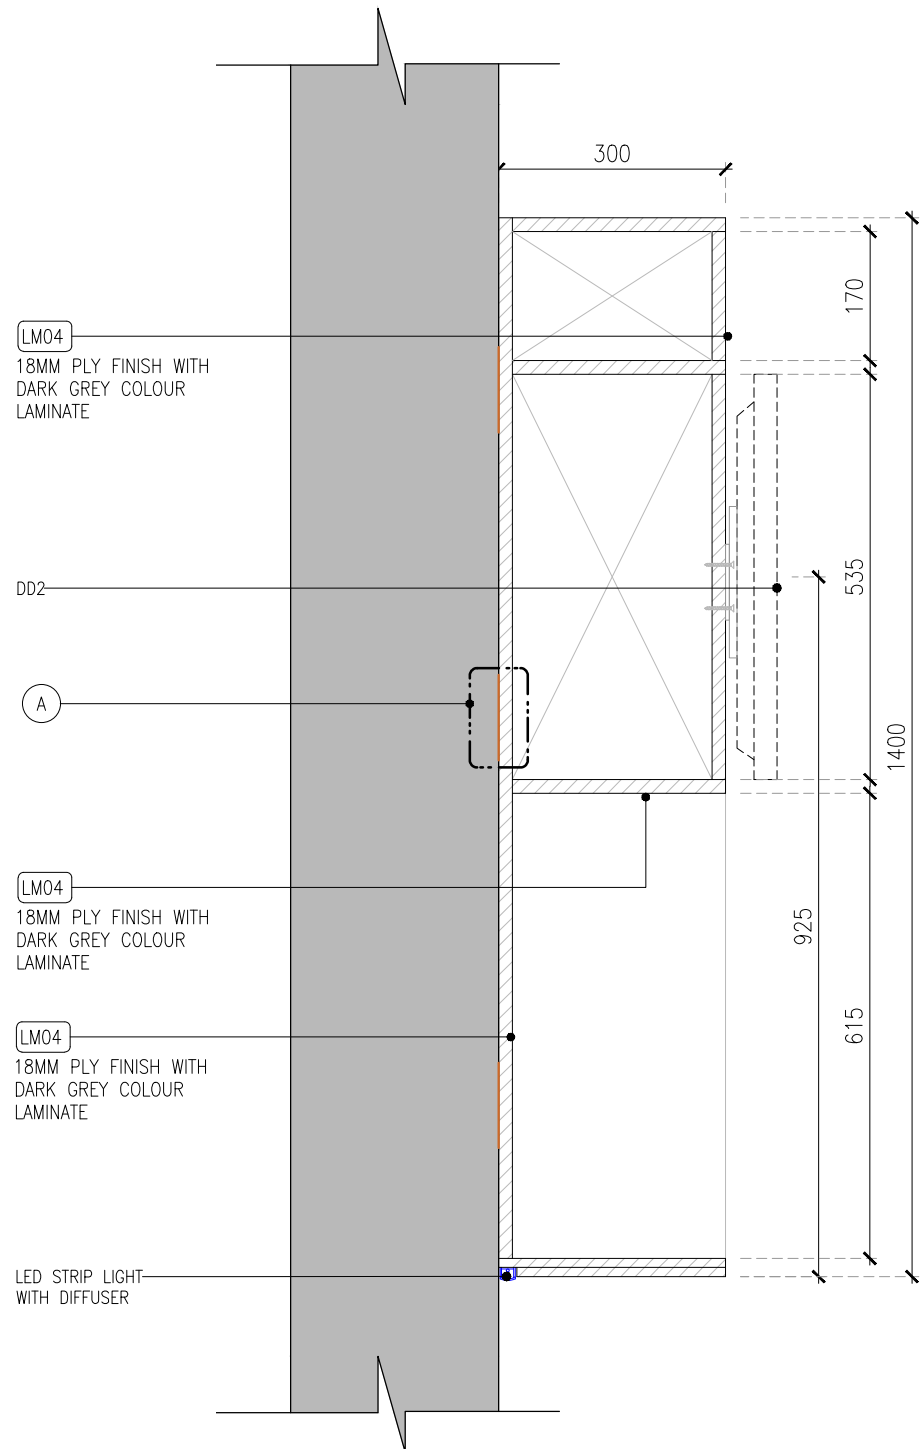


01 SECTION-01
04DE-412B 1:10

02 SECTION-02
04DE-412B 1:10

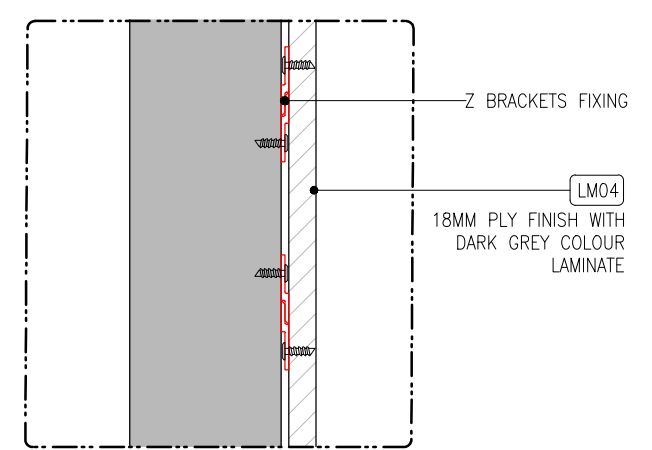

DETAIL-A

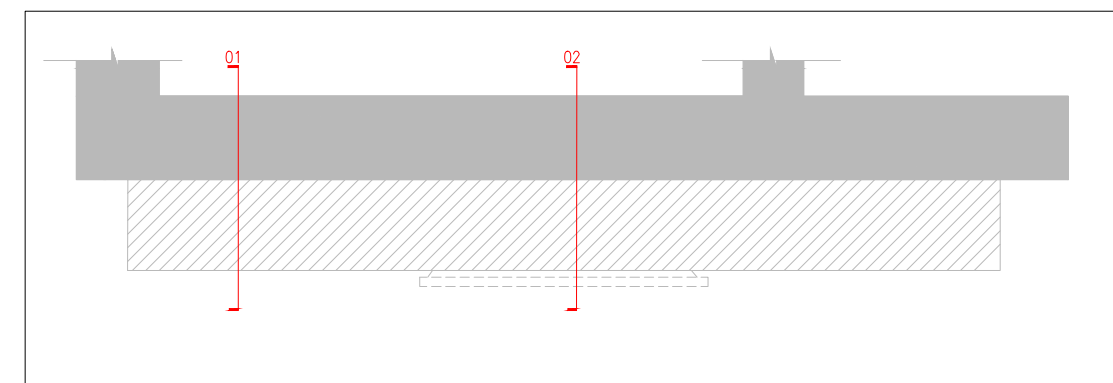

KEYPLAN

REV	DATE	DESCRIPTION	HOD	NM
T02	11.10.24	TENDER		
			DRN	CHK



PROJECT
CARLSJR FF018
GMR INTERNATIONAL
AIRPORT LIMITED,
HYDERABAD

DRAWING TITLE
J14-BAR-WALL MOUNTED SHELF
DETAIL-PART:C

SCALE 1:10 DATE 11.10.2024 DRAWN HOD A3 SHEET

STATUS
TENDER

ORG	PROJECT NO	DRAWING TYPE	NUMBER	REV
TFS	0000	04DE	412B	T02