


NOTES

- Dimensions to be read not scaled.
- Any discrepancy in the dimensions shall be brought to the notice of **Design Team** before execution on site.
- This drawing is for conceptualization of the fixture. Material thickness can be adjusted according to the structural or load transfer requirements. Note that overall dimensions shall remain same as specified in this drawing.

TOTAL AREA BIGGIES

TOTAL AREA	162 sqft
Kitchen Area	132 sqft
Counter Front	15'-3"

Design & Build
SWASTIK ENTERPRISES



Client




Project Name
**Biggies Burger
Kolkata Airport**

Drawing Title
Furniture Layout

Drawn By- Bharat	Drawing Number- BB-KA-01	Date- 15/12/2024
Checked By- Chhavi	Revision Number- R3	Scale- NTS

NOTES

- Dimensions to be read not scaled.
- Any discrepancy in the dimensions shall be brought to the notice of **Design Team** before execution on site.
- This drawing is for conceptualization of the fixture. Material thickness can be adjusted according to the structural or load transfer requirements. Note that overall dimensions shall remain same as specified in this drawing.

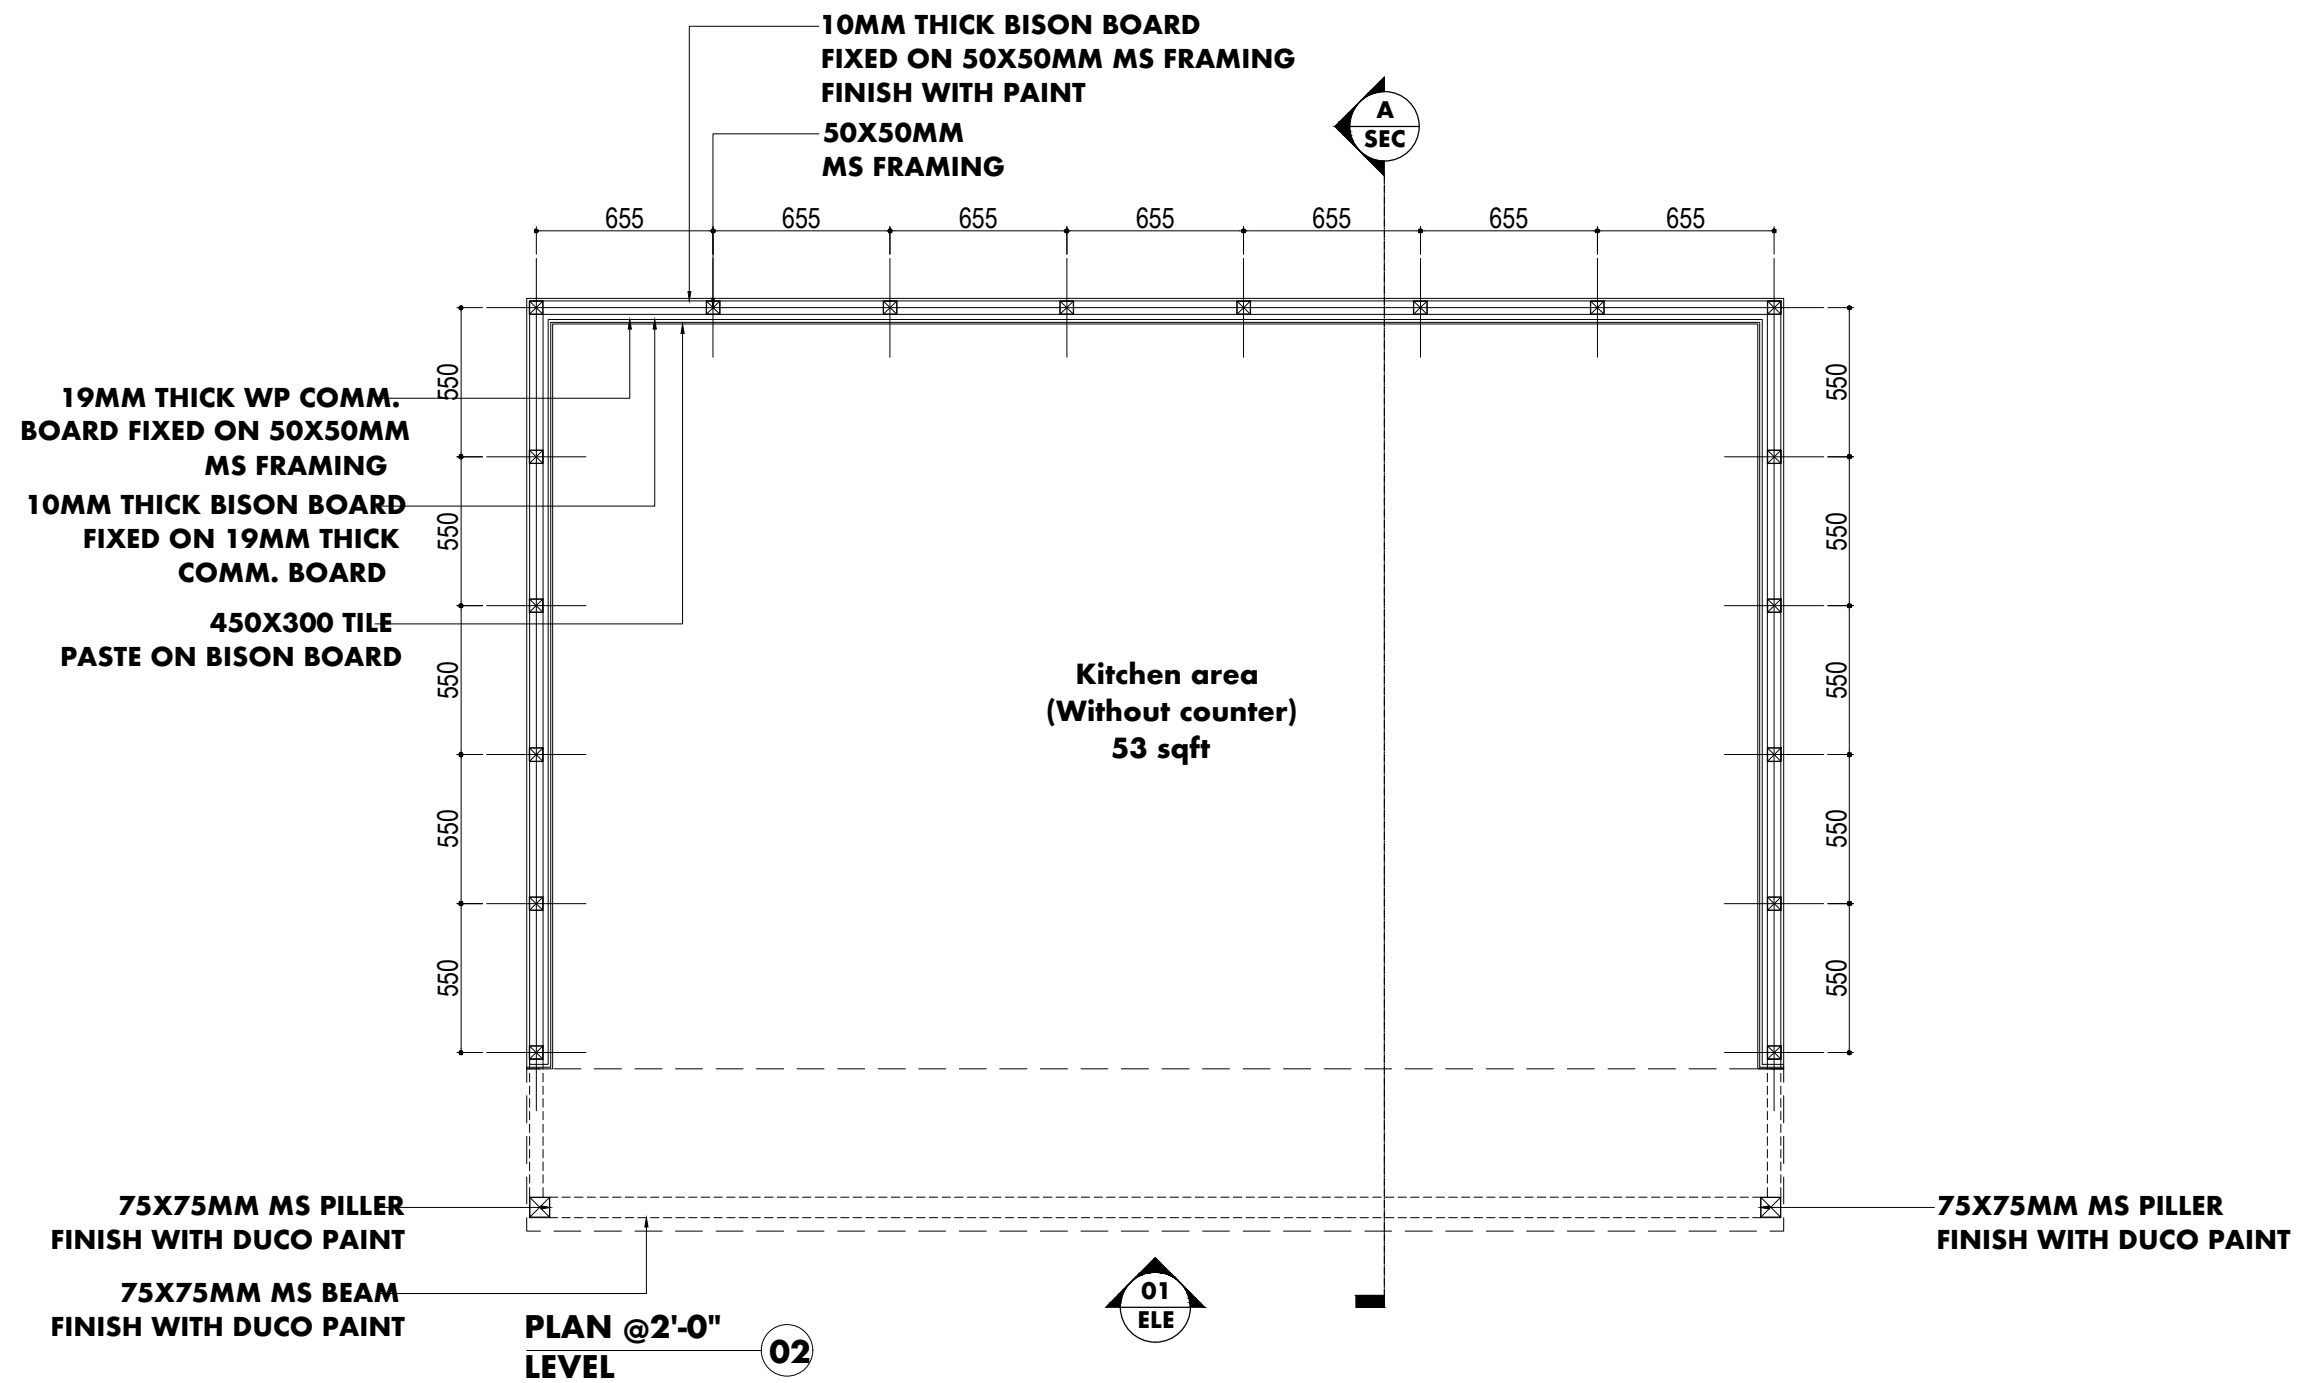

Design & Build

**SWASTIK
ENTERPRISES**



Client




Project Name

**Biggies Burger
Kolkata Airport**

Drawing Title

Partition Plan @2'-0" Height Layout

Drawn By- Bharat	Drawing Number- BB-KA-02	Date- 05/12/2024
Checked By- Chhavi	Revision Number- R3	Scale- NTS

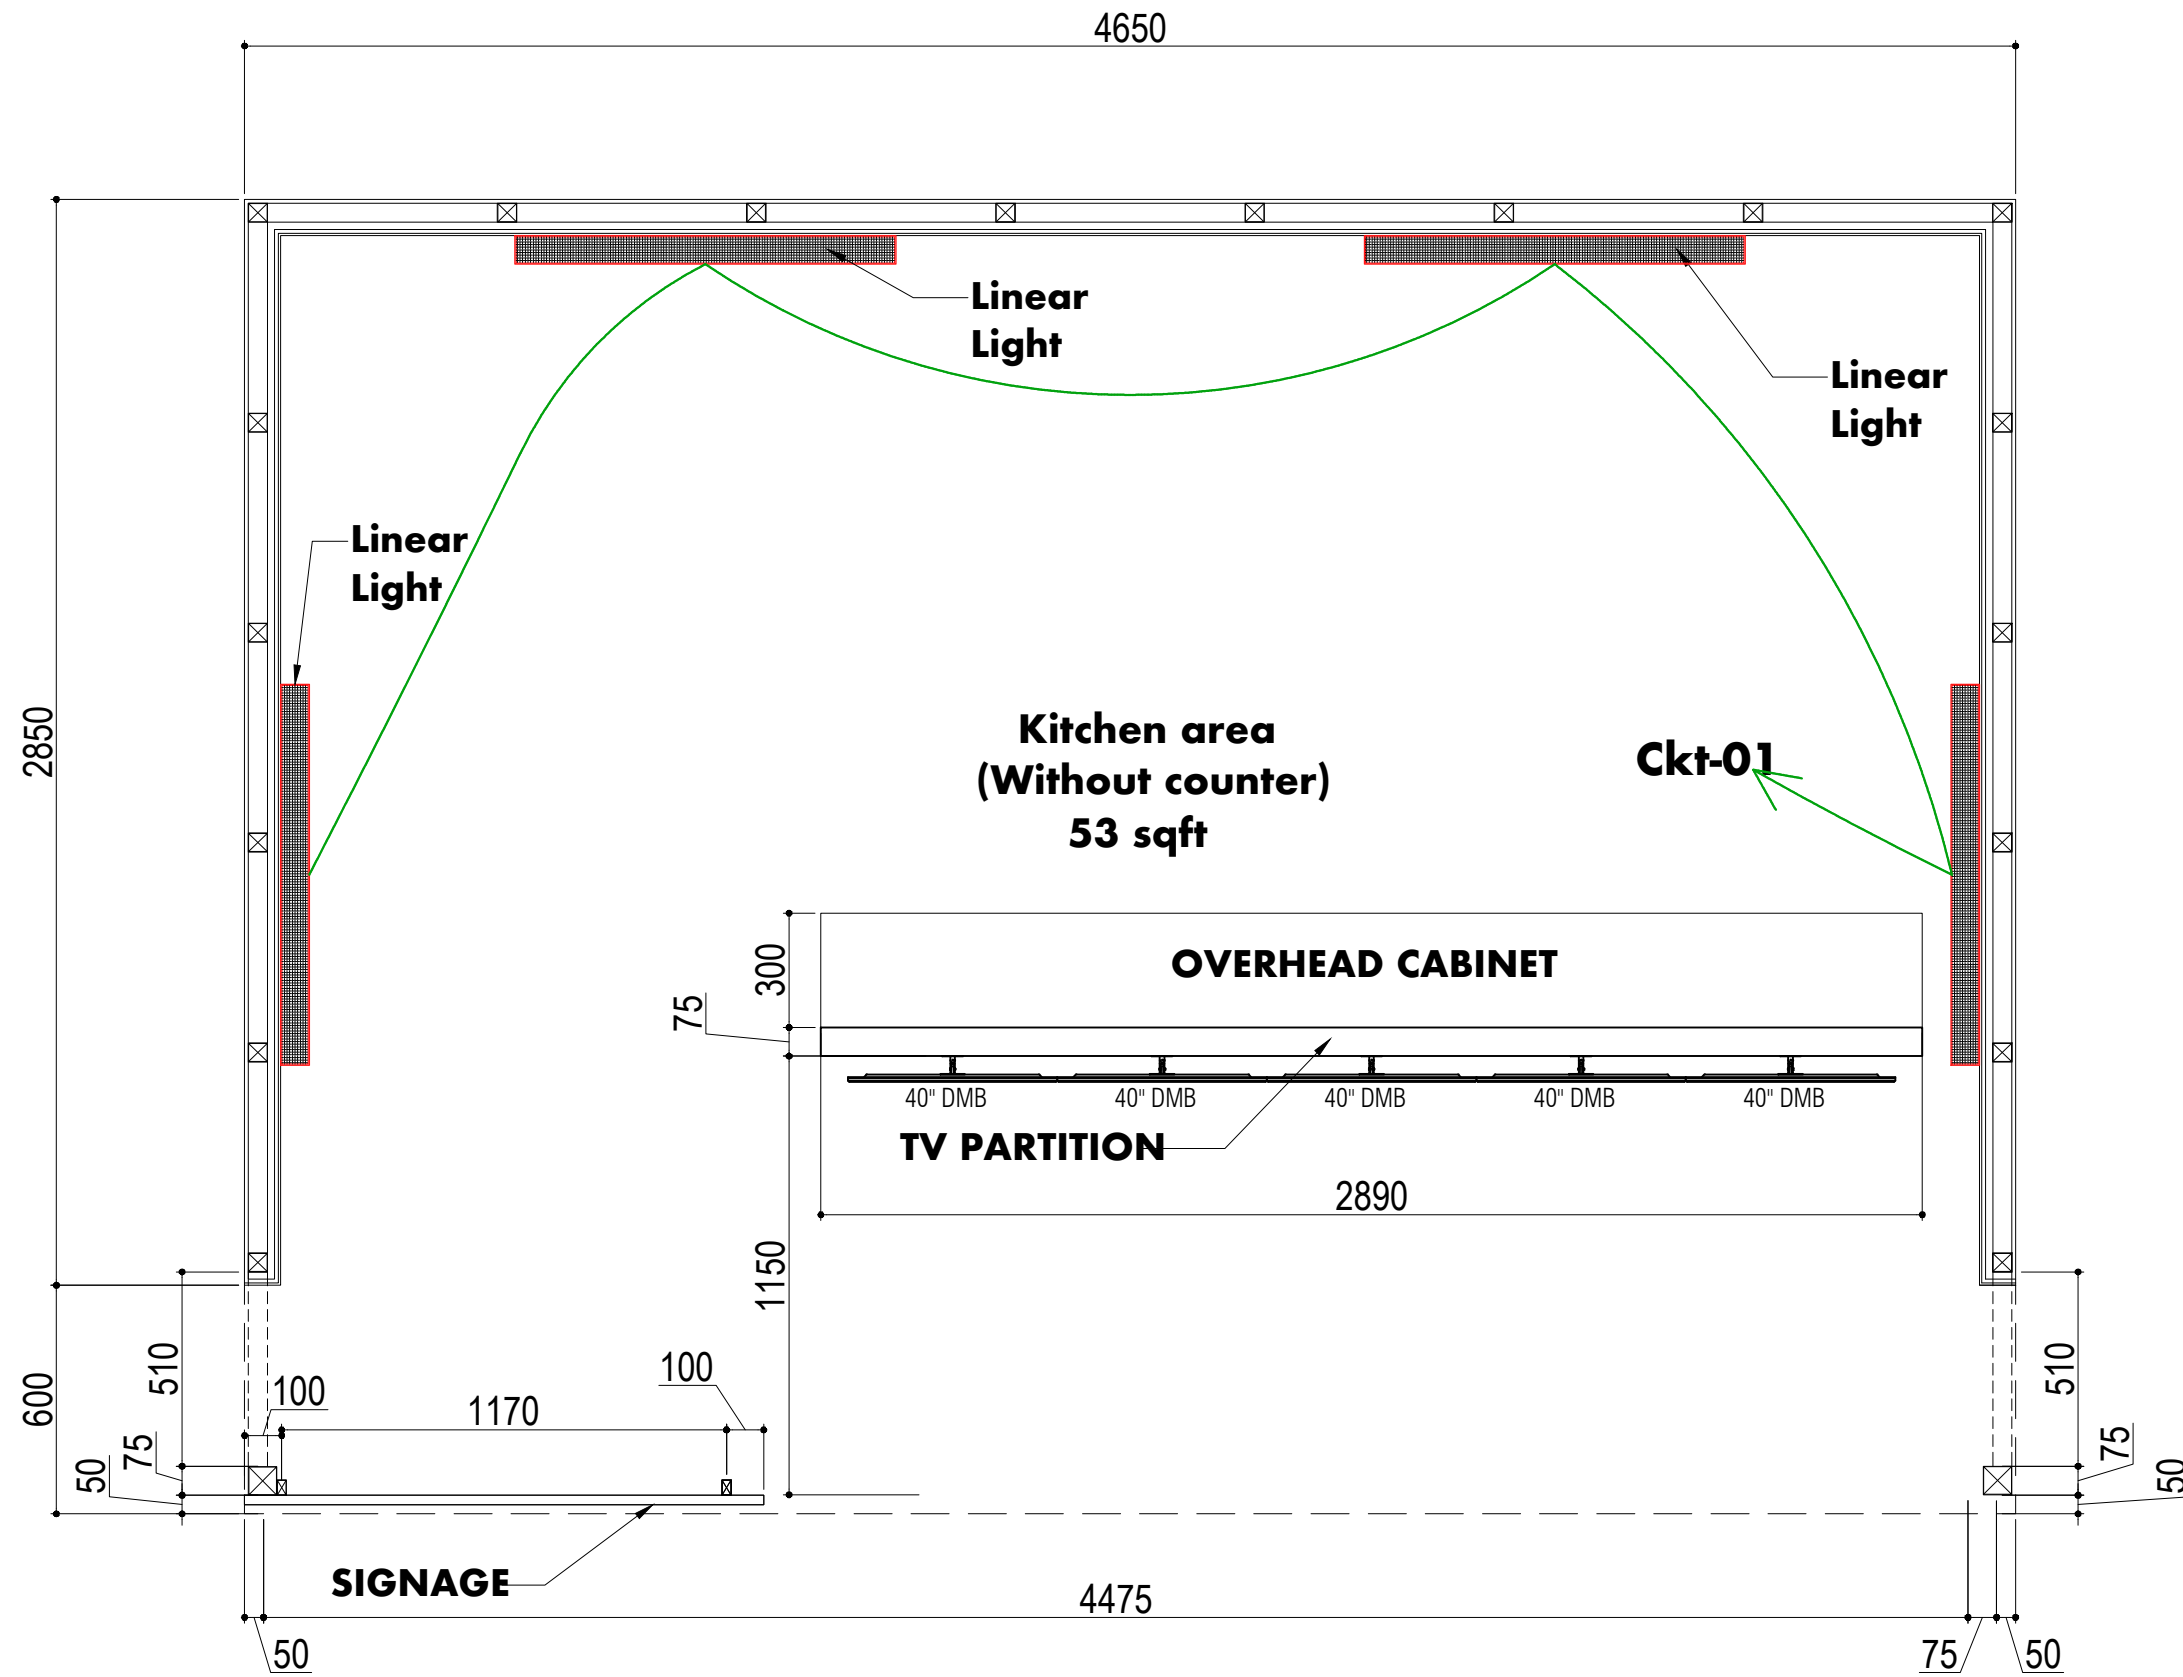

PLAN @Ceiling LEVEL 03

 
NOTES

- Dimensions to be read not scaled.
- Any discrepancy in the dimensions shall be brought to the notice of **Design Team** before execution on site.
- This drawing is for conceptualization of the fixture. Material thickness can be adjusted according to the structural or load transfer requirements. Note that overall dimensions shall remain same as specified in this drawing.

Design & Build
SWASTIK ENTERPRISES




Client



Project Name
Biggies Burger
Kolkata Airport

Drawing Title
Plan @ Ceiling Level Layout

Drawn By- Bharat	Drawing Number- BB-KA-03	Date- 05/12/2024
Checked By- Chhavi	Revision Number- R3	Scale- NTS

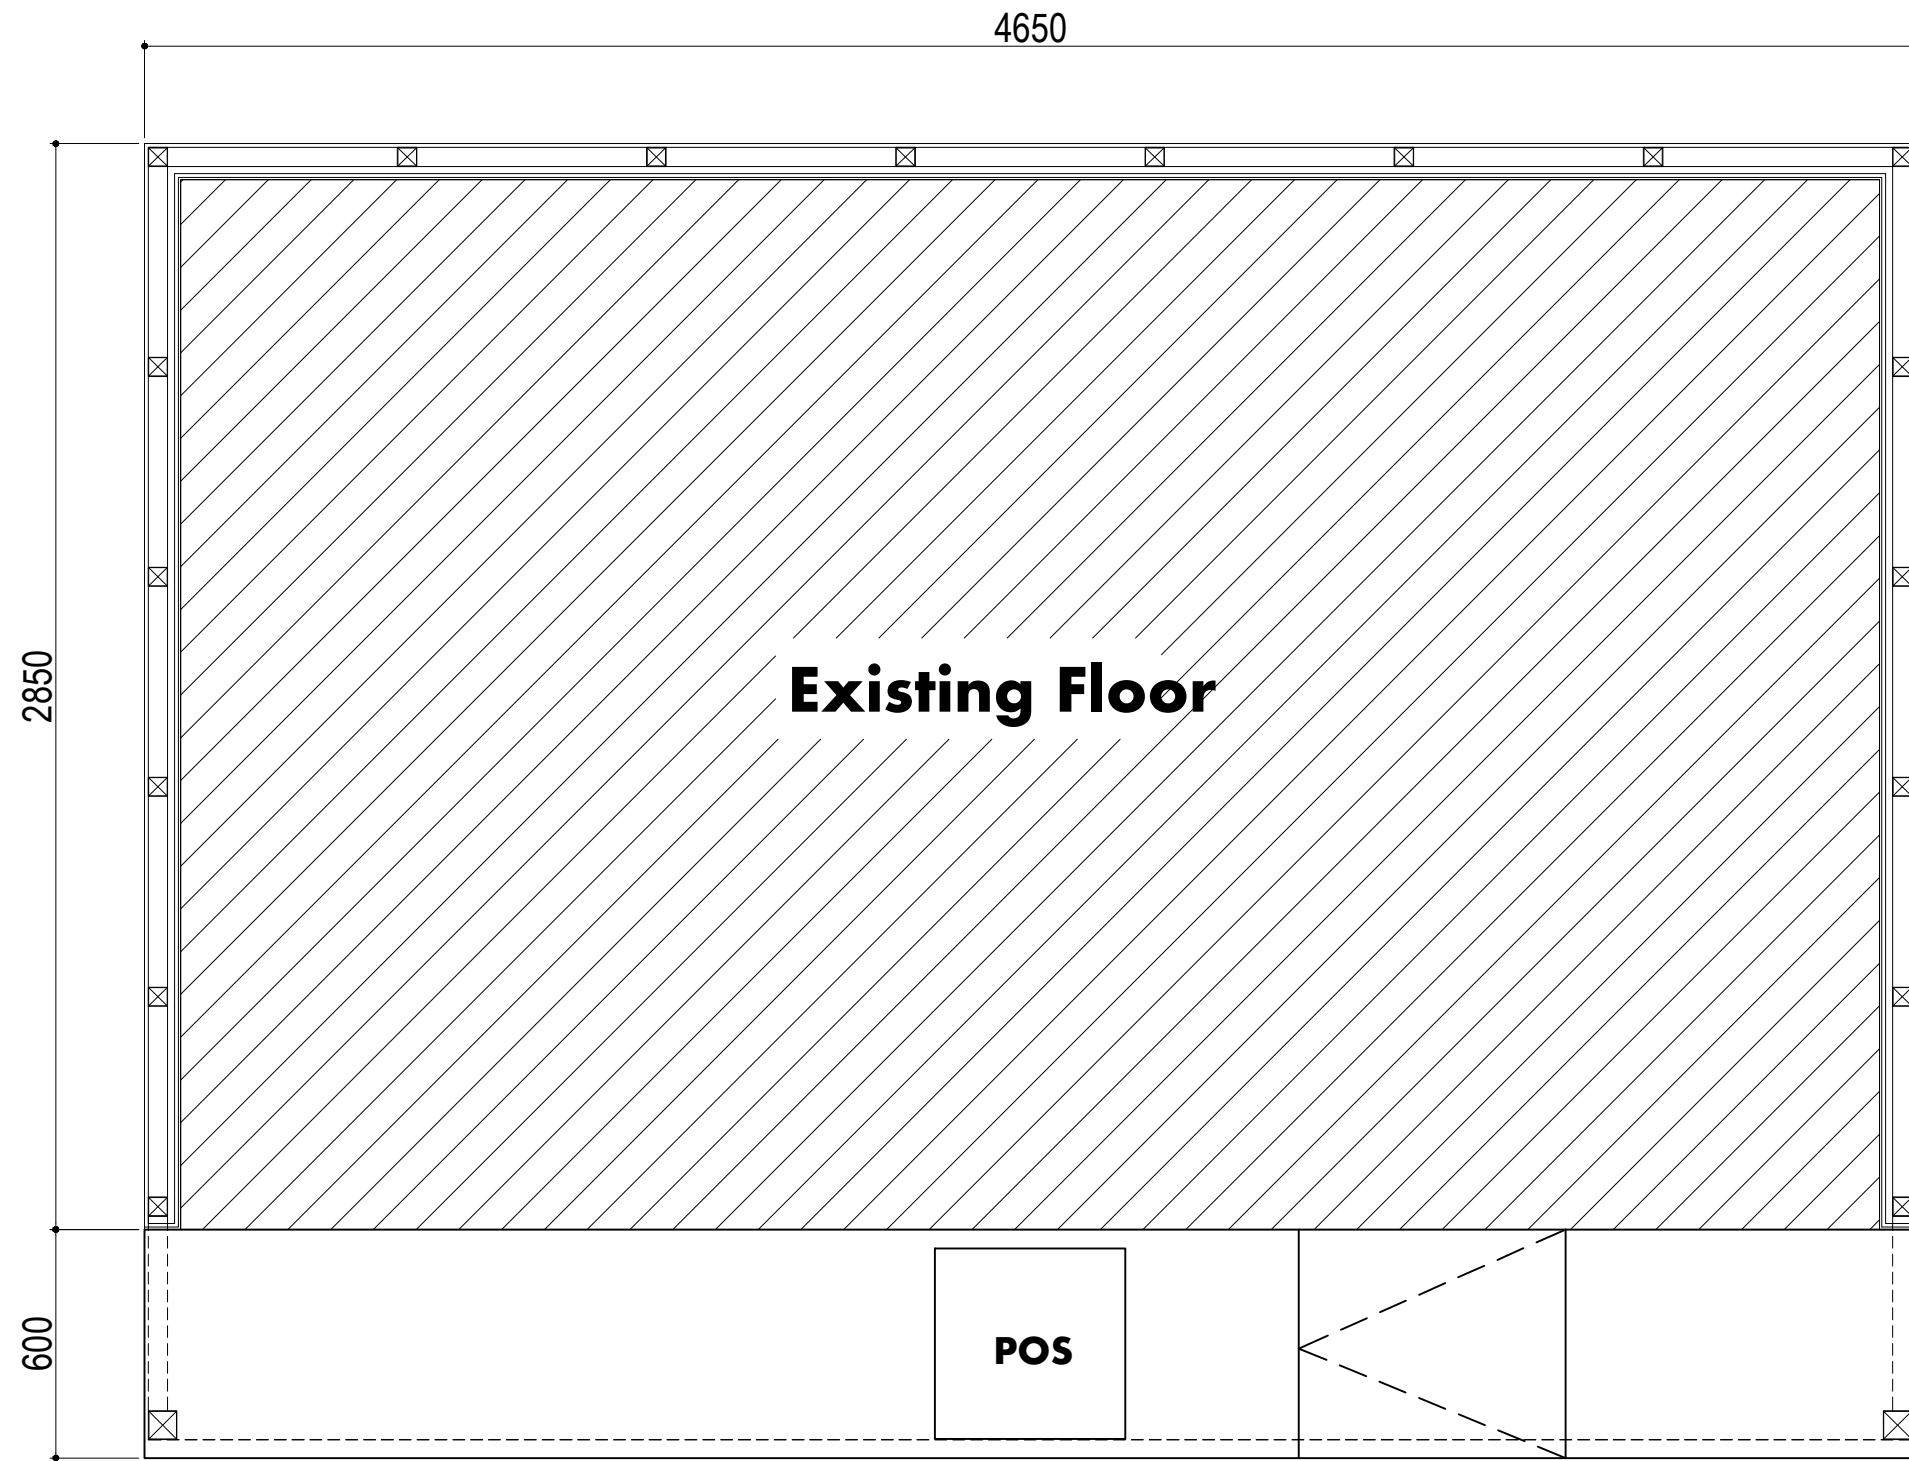

FLOORING PLAN 04

- NOTES**
- Dimensions to be read not scaled.
 - Any discrepancy in the dimensions shall be brought to the notice of **Design Team** before execution on site.
 - This drawing is for conceptualization of the fixture. Material thickness can be adjusted according to the structural or load transfer requirements. Note that overall dimensions shall remain same as specified in this drawing.

TOTAL AREA BIGGIES

--	--

Design & Build
SWASTIK ENTERPRISES

Client

Project Name
Biggies Burger
Kolkata Airport

Drawing Title
Flooring Layout

Drawn By- Bharat	Drawing Number- BB-KA-04	Date- 05/12/2024	
Checked By- Chhavi	Revision Number- R3	Scale- NTS	

NOTES

- Dimensions to be read not scaled.
- Any discrepancy in the dimensions shall be brought to the notice of **Design Team** before execution on site.
- This drawing is for conceptualization of the fixture. Material thickness can be adjusted according to the structural or load transfer requirements. Note that overall dimensions shall remain same as specified in this drawing.

ELECTRICAL LEGEND


	ELE SWITCH CONTROL 1-PH/6A
	ELE SWITCH & SOCKET 1-PH/16A SUPPLY
	ELE SWITCH & SOCKET 1-PH/6A SUPPLY
	LOOSE WIRE POINT FOR MAIN SIGNAGE BOARD 16AMP
	DATA POINT
	CASH COUNTER POINTS ON FLOOR 6A x 6 SOCKET & 2 SWITCH
	ELE SWITCH CONTROL 1-PH/16A
	ELE WIRE POINT TAKEN FROM WALL AND LEFT 1 MM FREE
	INDUSTRIAL SWITCH & SOCKET 1-PH/16A SUPPLY
	DISTRIBUTION BOARD

Design & Build

SWASTIK ENTERPRISES



 Client




Project Name

**Biggies Burger
Kolkata Airport**

Drawing Title

Electrical Layout

Drawn By- Bharat	Drawing Number- BB-KA-05	Date- 05/12/2024
Checked By- Chhavi	Revision Number- R3	Scale- NTS

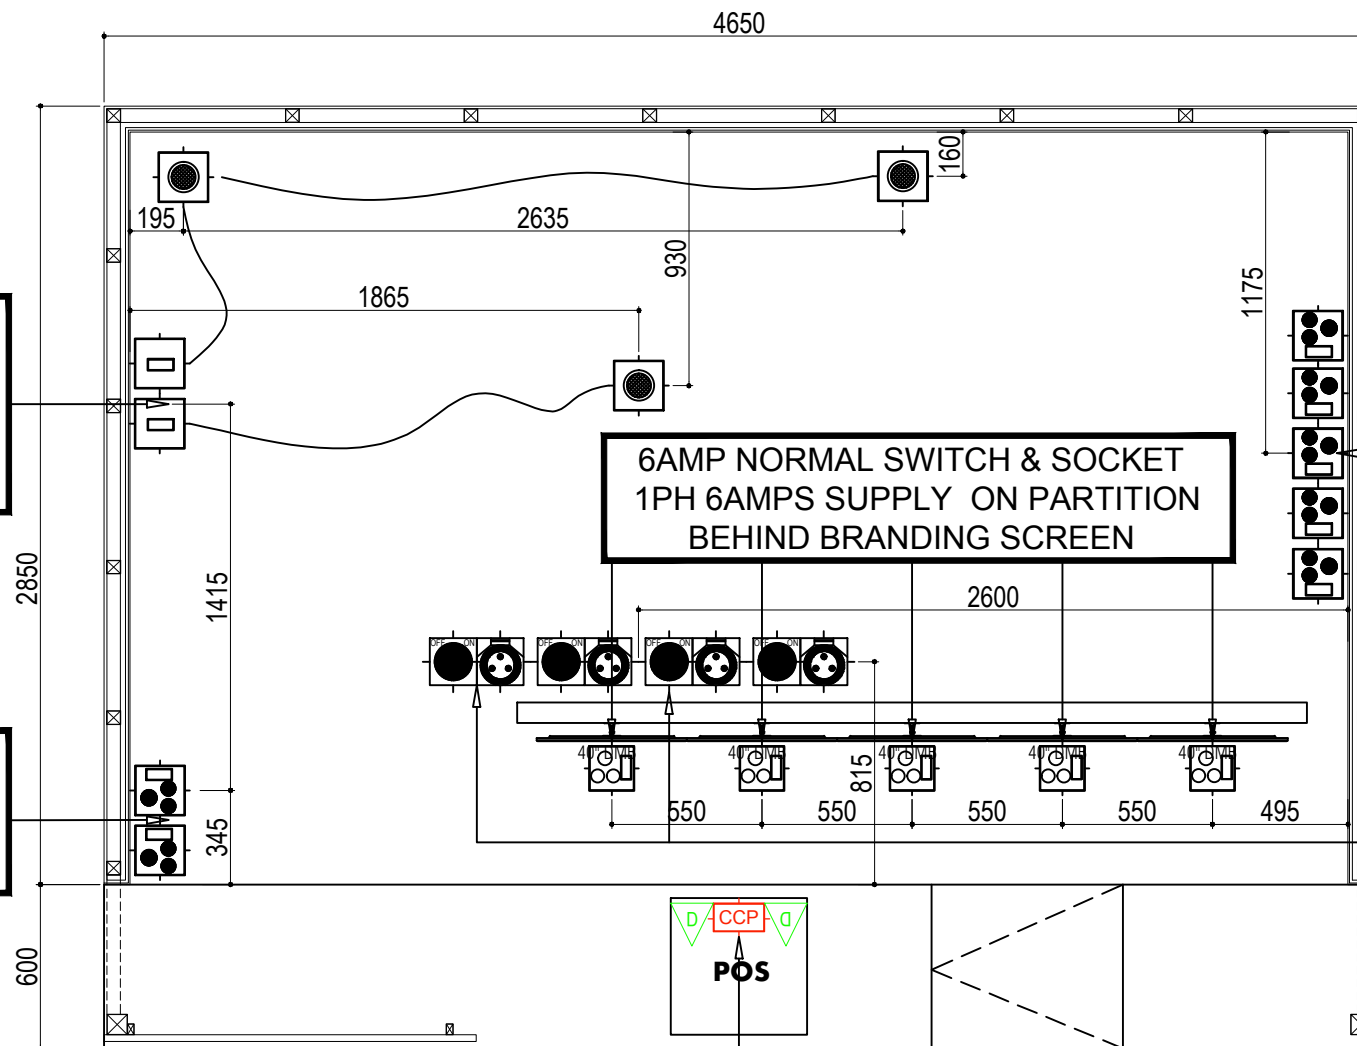

ELECTRICAL SUPPLY DROPPED FROM CEILING WITH 1PH SUPPLY 1 MT FREE CABLE & SWITCH CONTROL AT 1200 ON WALL

16AMP NORMAL SWITCH & SOCKET AT 1200MM HT FROM FFL

LOOSE WIRE POINT FOR LED STRIP LIGHT, AT 3100MM Ht FROM FFL

6AMP NORMAL SWITCH & SOCKET 1PH 6AMPS SUPPLY ON PARTITION BEHIND BRANDING SCREEN

16AMP NORMAL SWITCH & SOCKET AT 1200MM HT FROM FFL

INDUSTRIAL SWITCH & SOCKET- 1PH 16AMPS, DROPPED FROM CEILING USING ANGLE FRAME SUPPORT @ 1800MM FROM FFL

CCP & DATA POINT AS PER COUNTER DETAIL

ELECTRICAL PLAN 05


**CONNECT WITH MALL
EXISTING DRAIN**

4650

**CONNECT WITH MALL
EXISTING DRAIN**

**PEPSI DRAIN FLEXIBLE PIPE
CONNECT TO WALL DRAIN**

**FLEXIBLE PIPE
CONNECT
TO WALL DRAIN**

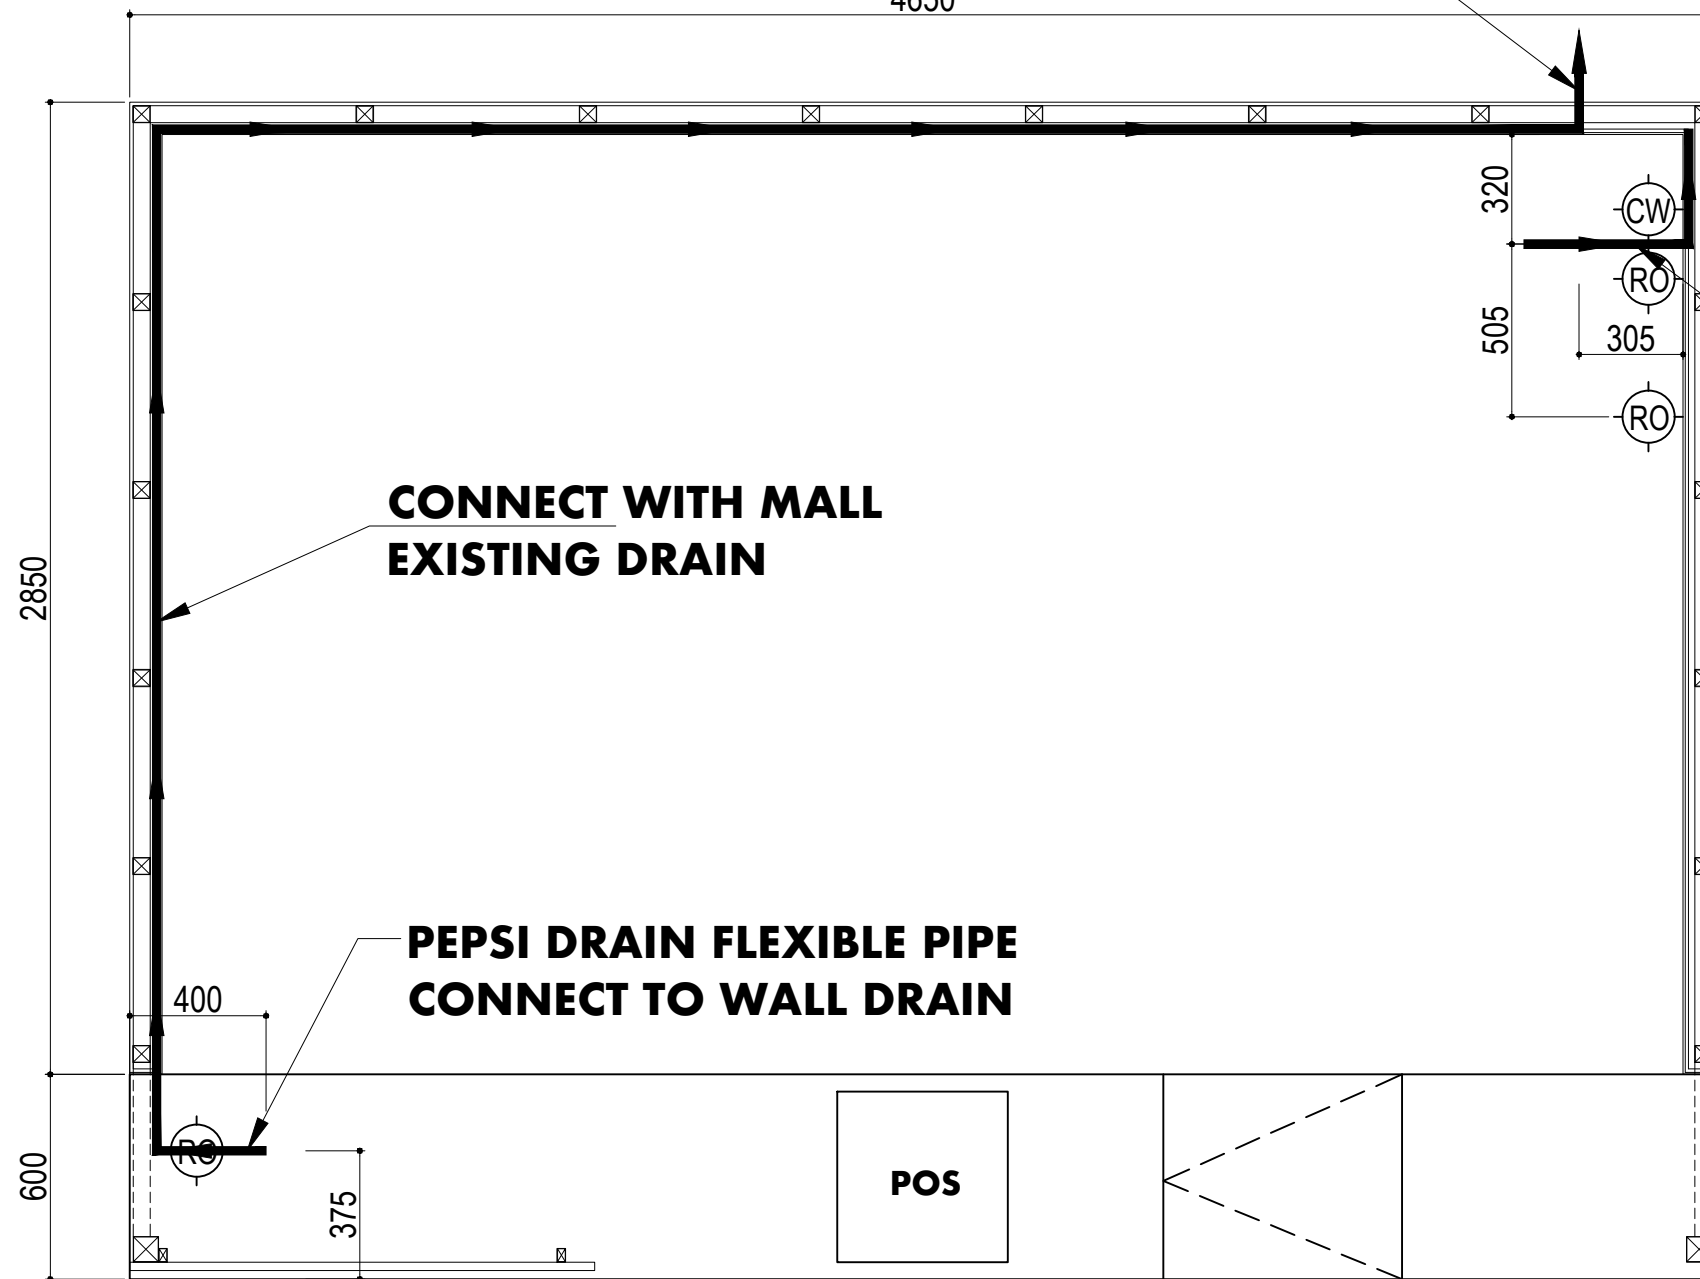

PLUMBING PLAN

06

WATER PRESSURE MINIMUM 1.5 BAR REQUIRED	
	COLD SOFT WATER INLET @450MM HT AFFL (200 PPM) (Size:Ø15mm)
	RO WATER INLET AT @450MM HT AFFL (0 PPM) (Size:Ø15mm)
	FLOOR DRAIN WITH CI OR CPVC PIPES NEED TO BE USED (Size:Ø50mm)
	FLOOR DRAIN WITH CPVC PIPES NEED TO BE USED 105mm DIA DRAIN OUTLET WITH "P"TRAP

 
NOTES

- Dimensions to be read not scaled.
- Any discrepancy in the dimensions shall be brought to the notice of **Design Team** before execution on site.
- This drawing is for conceptualization of the fixture. Material thickness can be adjusted according to the structural or load transfer requirements. Note that overall dimensions shall remain same as specified in this drawing.

Design & Build
SWASTIK ENTERPRISES




Client




Project Name
Biggies Burger
Kolkata Airport

Drawing Title
Plumbing Layout

Drawn By- Bharat	Drawing Number- BB-KA-06	Date- 05/12/2024
Checked By- Chhavi	Revision Number- R3	Scale- NTS

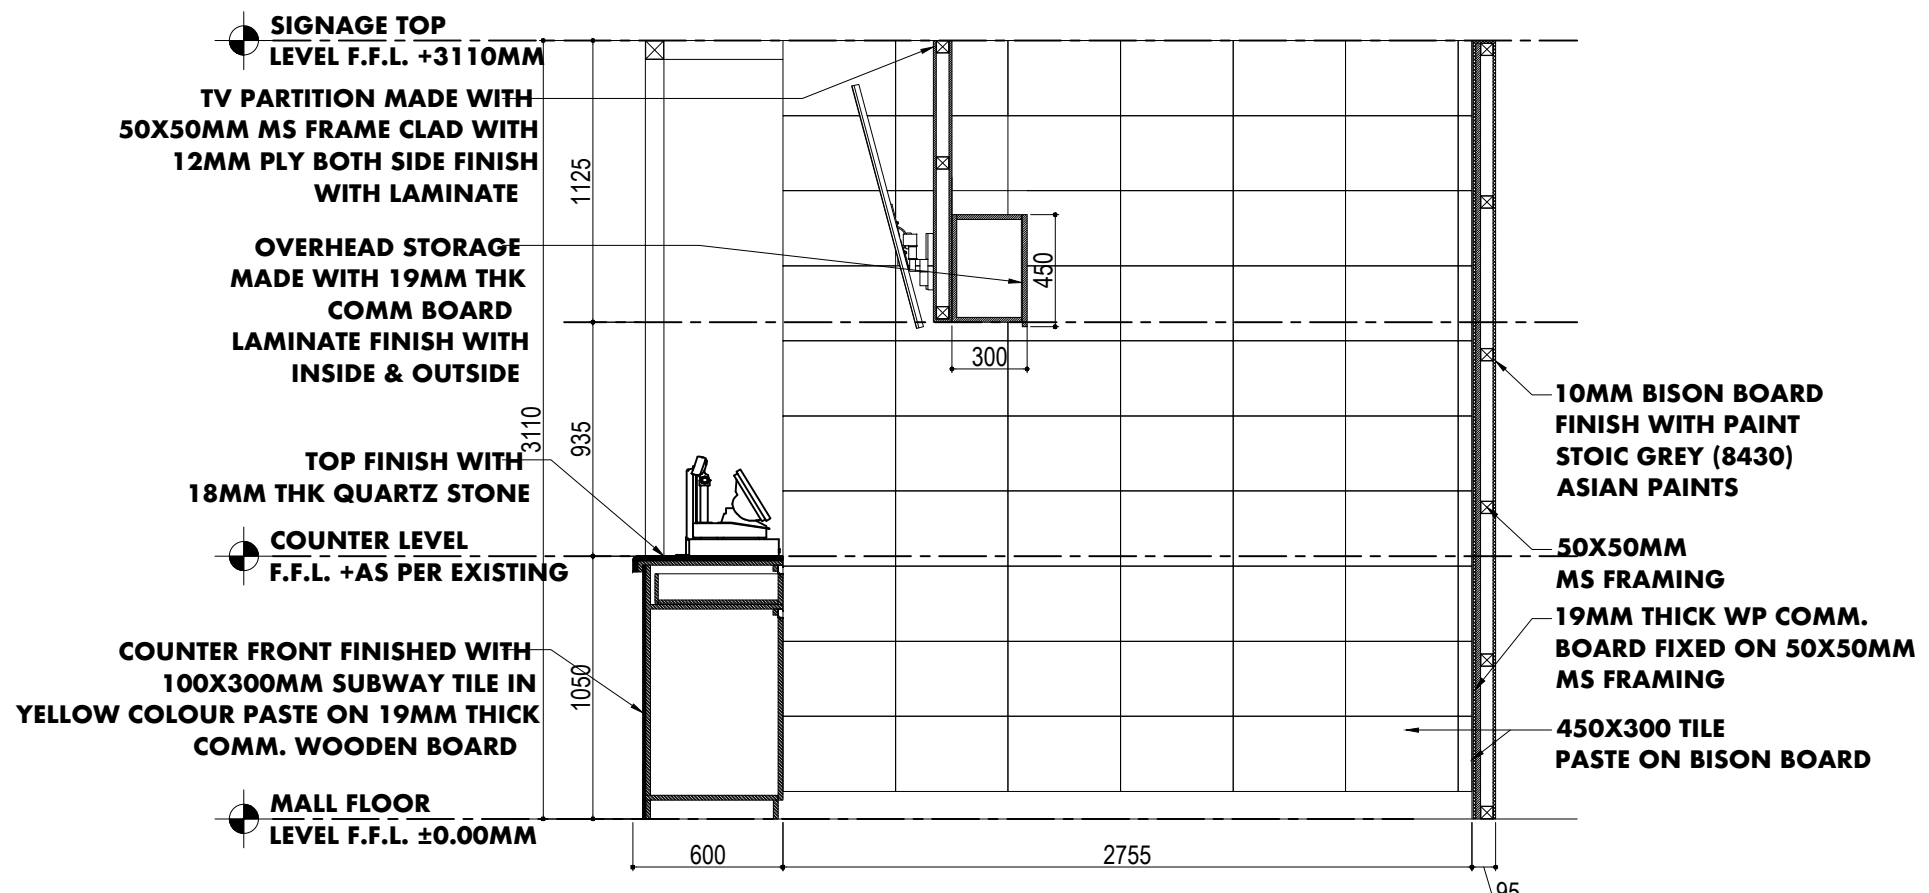

SECTION AA' 07

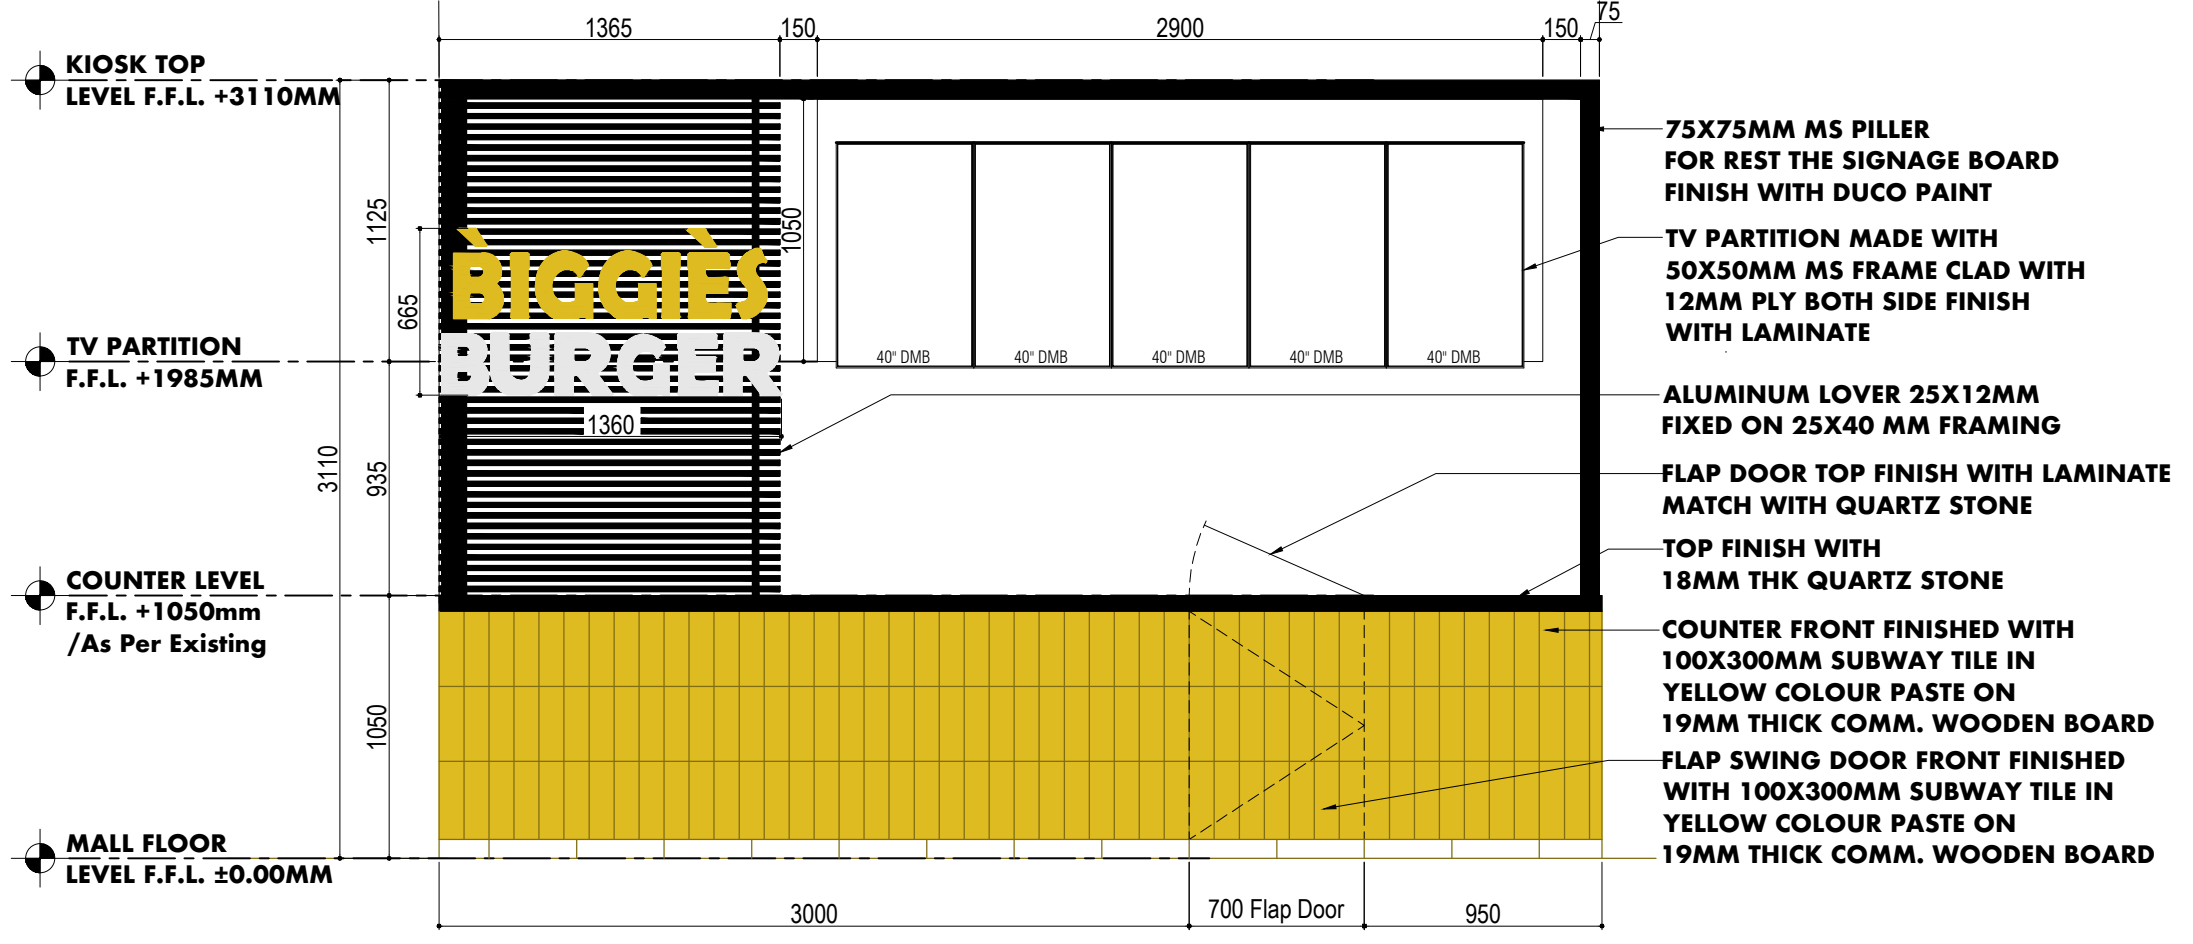

FRONT ELEVATION 08

 
NOTES

- Dimensions to be read not scaled.
- Any discrepancy in the dimensions shall be brought to the notice of **Design Team** before execution on site.
- This drawing is for conceptualization of the fixture. Material thickness can be adjusted according to the structural or load transfer requirements. Note that overall dimensions shall remain same as specified in this drawing.

Design & Build
SWASTIK ENTERPRISES



Client
Beamer Brands




Project Name
Biggies Burger
Kolkata Airport

Sectional Elevations

Drawn By- Bharat	Drawing Number- BB-KA-07	Date- 15/12/2024
Checked By- Chhavi	Revision Number- R3	Scale- NTS

NOTES

- Dimensions to be read not scaled.
- Any discrepancy in the dimensions shall be brought to the notice of **Design Team** before execution on site.
- This drawing is for conceptualization of the fixture. Material thickness can be adjusted according to the structural or load transfer requirements. Note that overall dimensions shall remain same as specified in this drawing.

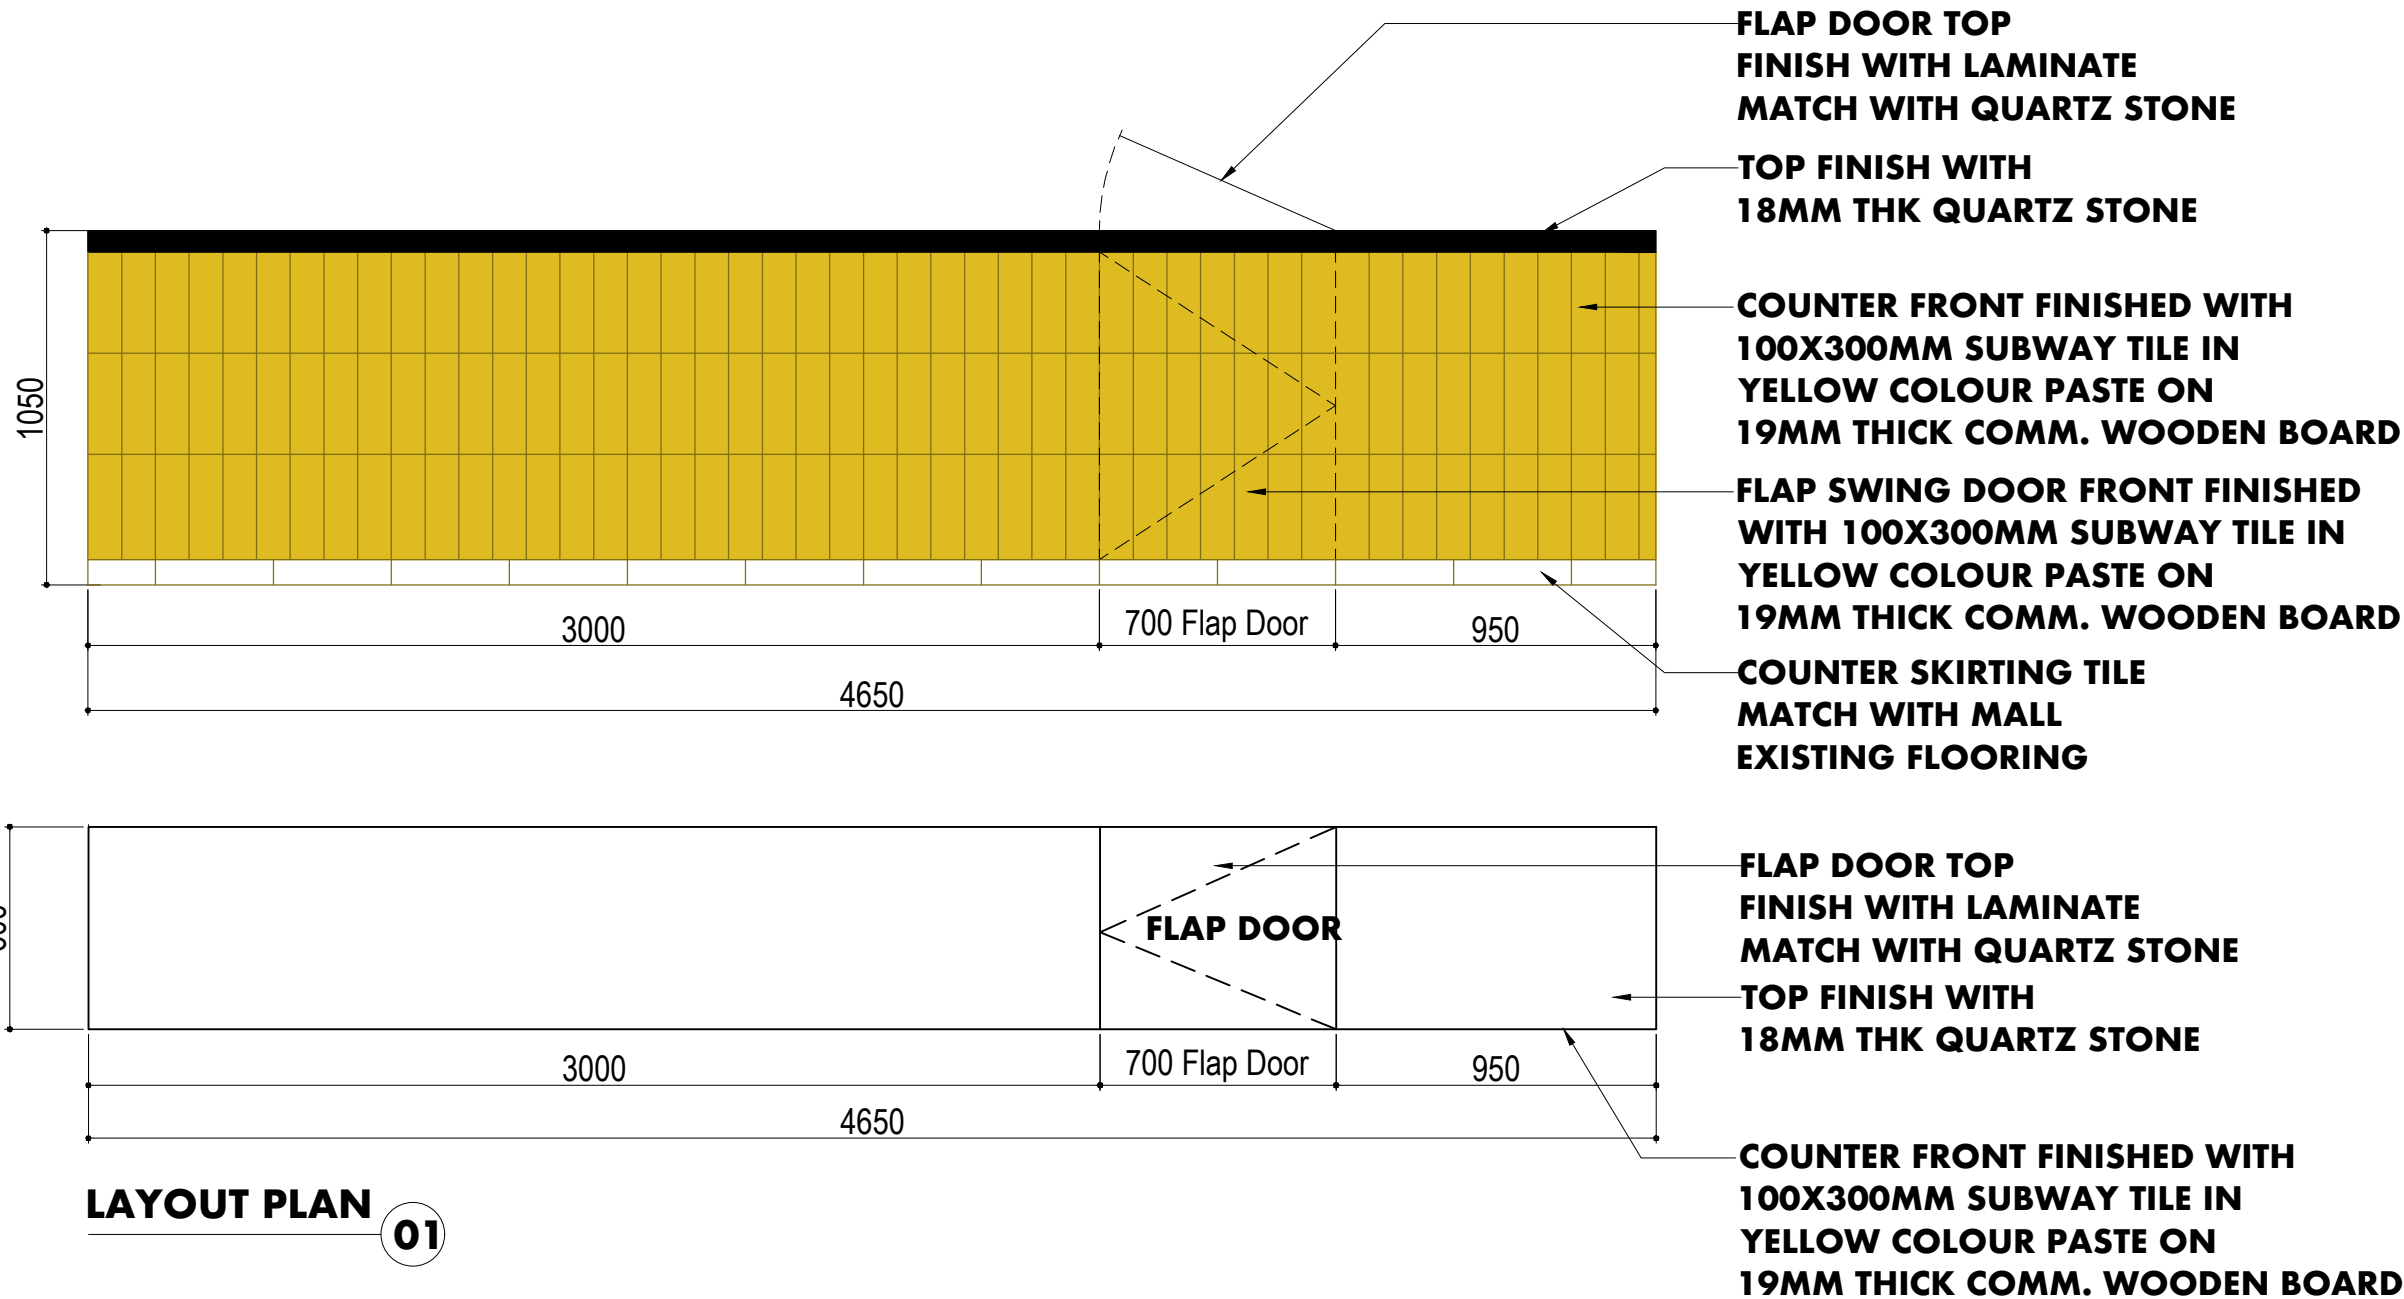

LAYOUT PLAN 01

Design & Build
SWASTIK ENTERPRISES




Client



Project Name
Biggies Burger
Kolkata Airport



Drawing Title
Counter Front Detail



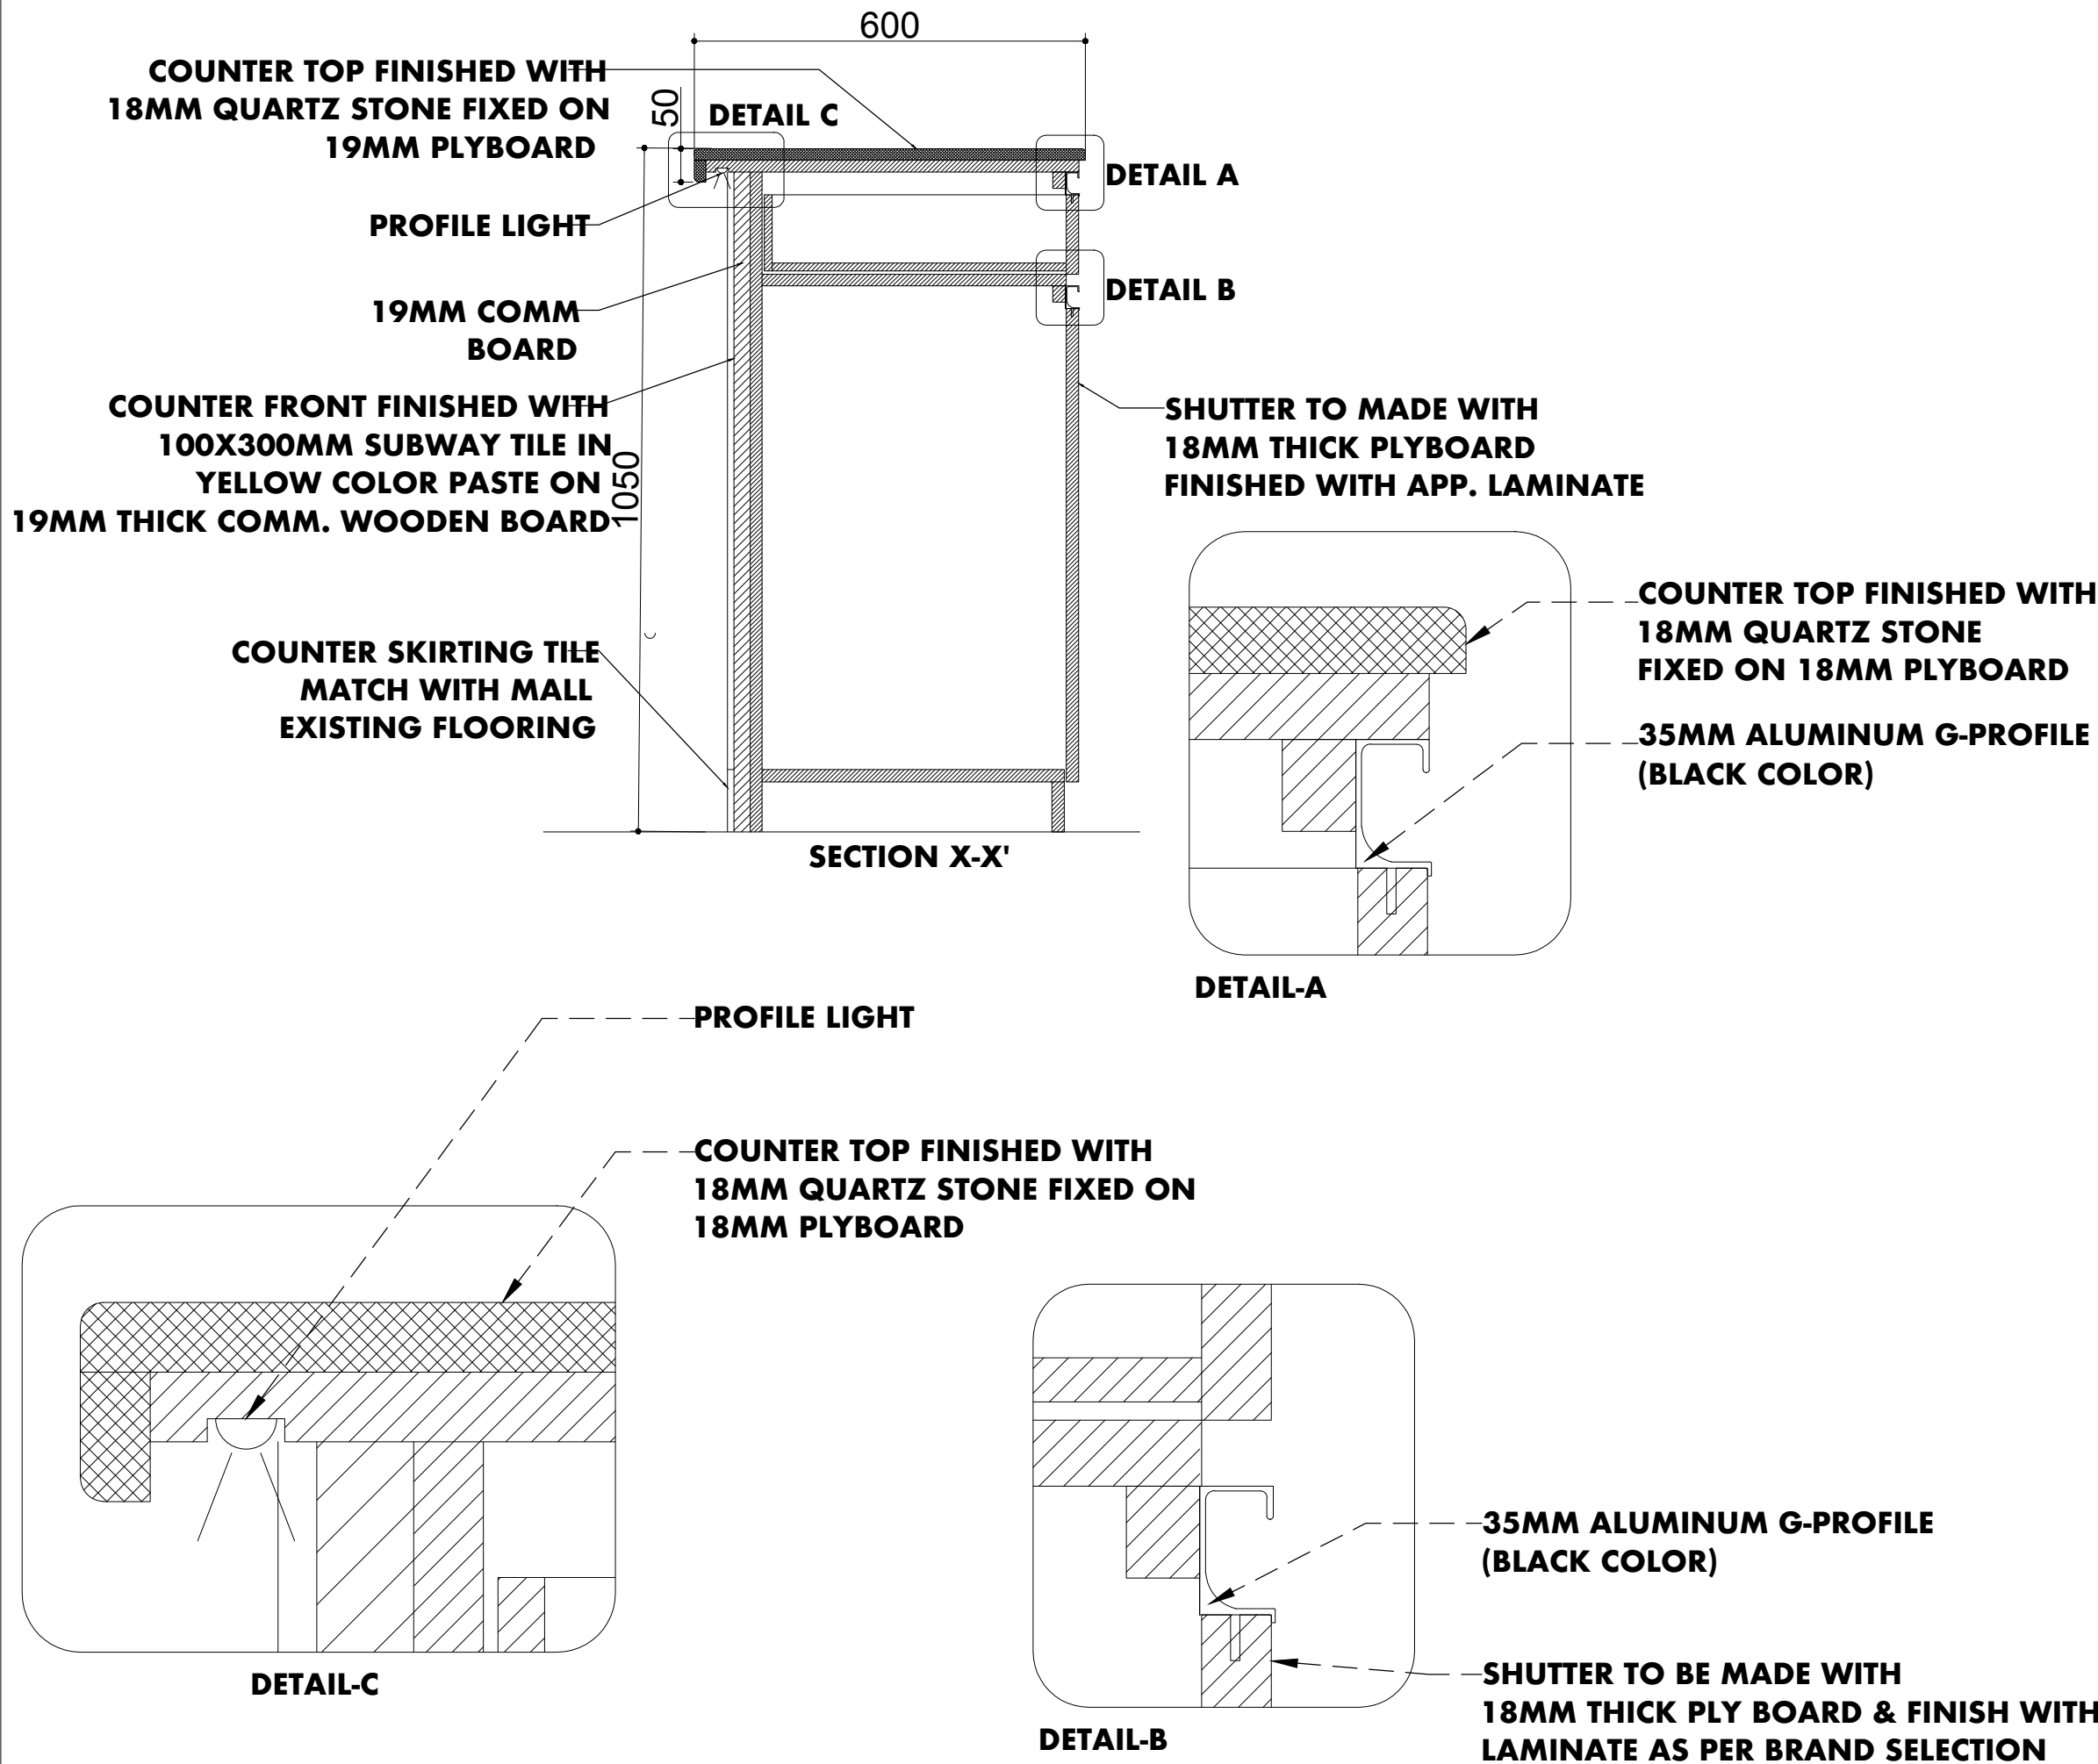
Drawn By- Bharat	Drawing Number- BB-KA-08	Date- 15/12/2024
Checked By- Chhavi	Revision Number- R3	Scale- NTS



NOTES

- Dimensions to be read not scaled.
- Any discrepancy in the dimensions shall be brought to the notice of *Design Team* before execution on site.
- This drawing is for conceptualization of the fixture. Material thickness can be adjusted according to the structural or load transfer requirements. Note that overall dimensions shall remain same as specified in this drawing.


Design & Build		
SWASTIK ENTERPRISES		
		
Client		
		
Project Name		
Biggies Burger		
Kolkata Airport		
Drawing Title		
Counter Sectional Details		
Drawn By-	Drawing Number-	Date-
Bharat	BB-KA-09	15/12/2024
Checked By-	Revision Number-	Scale-
Chhavi	R3	NTS

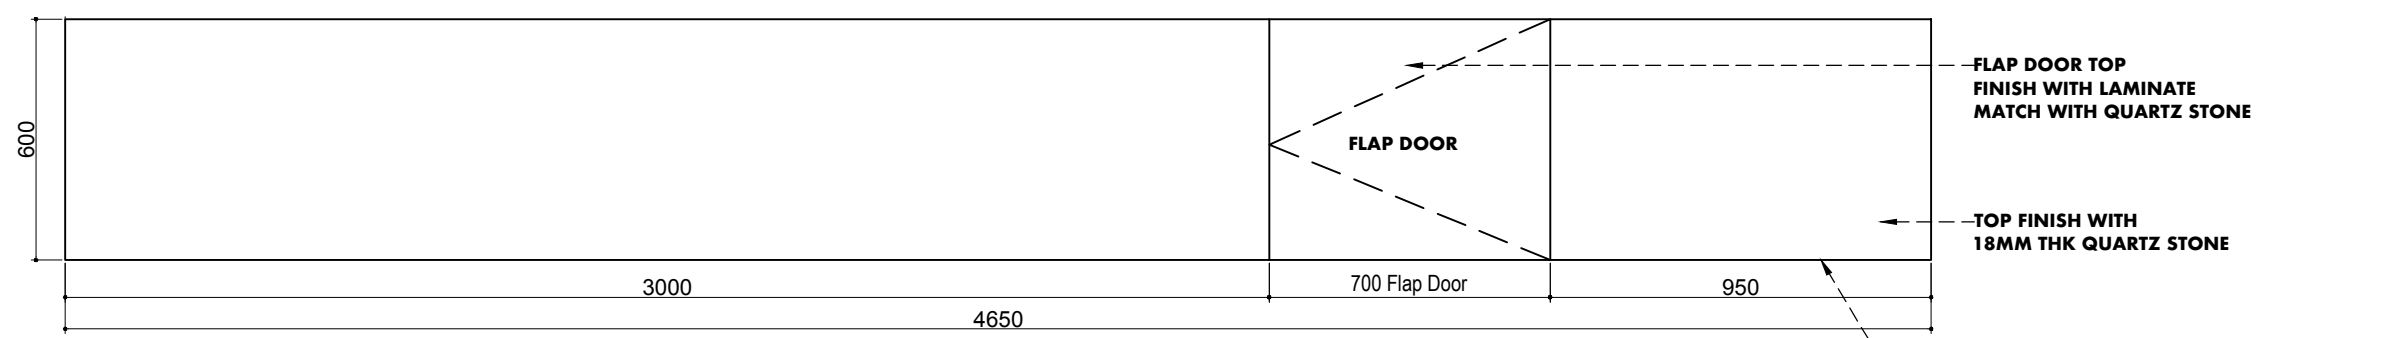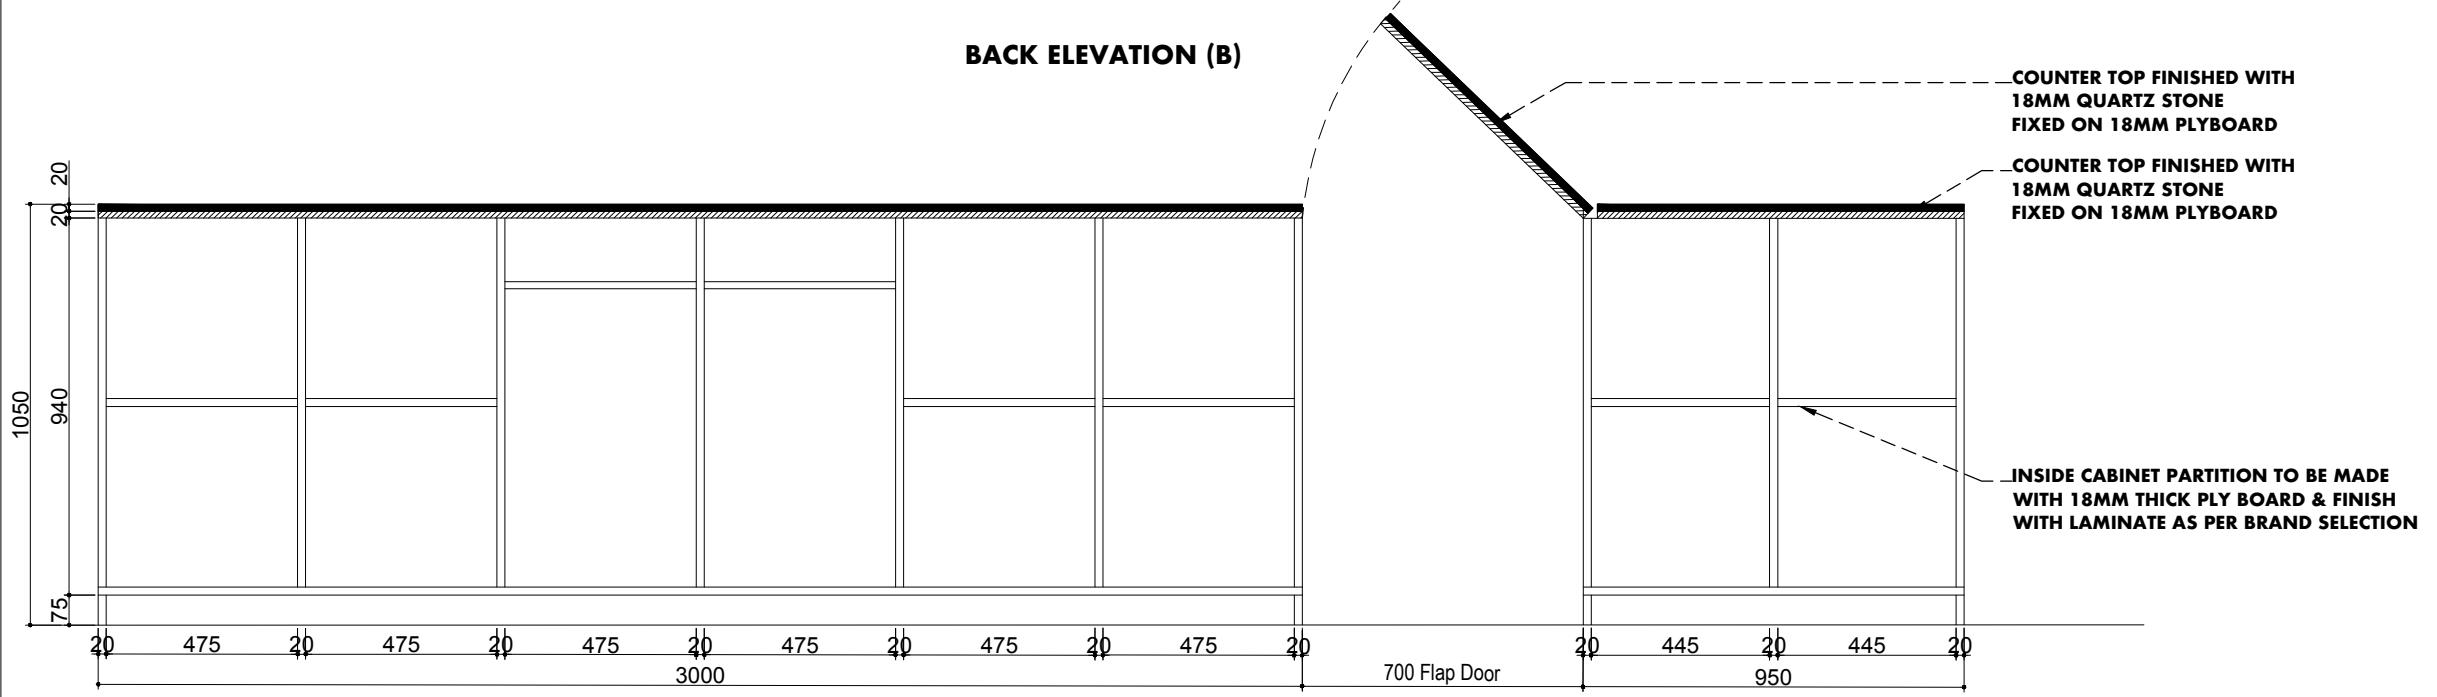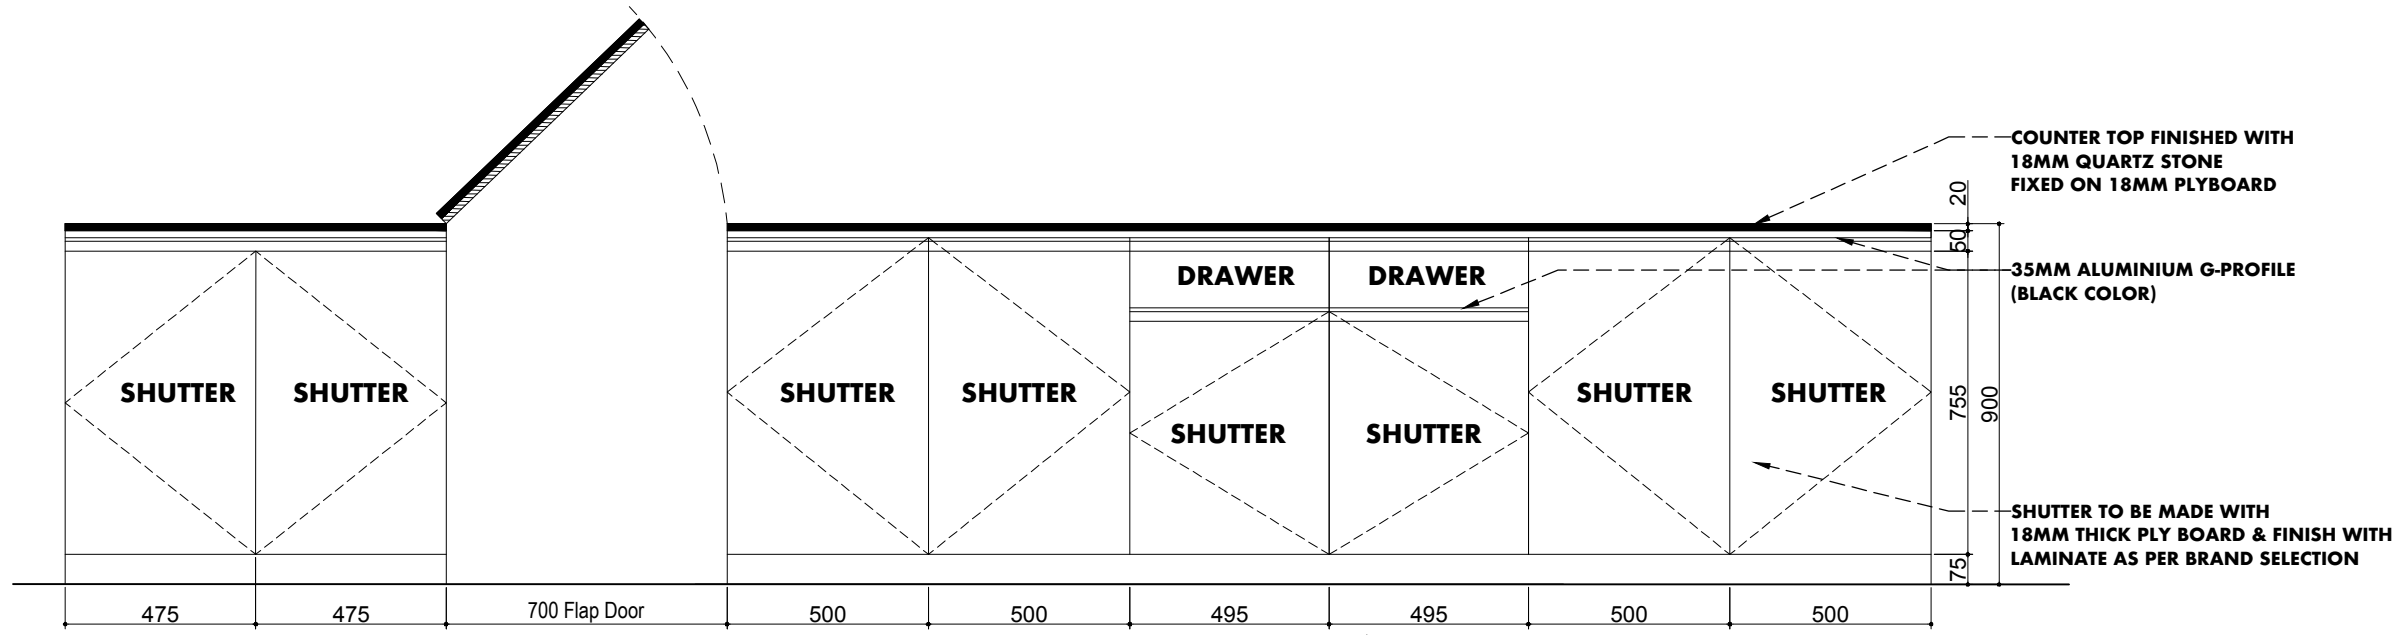

NOTES

- Dimensions to be read not scaled.
- Any discrepancy in the dimensions shall be brought to the notice of **Design Team** before execution on site.
- This drawing is for conceptualization of the fixture. Material thickness can be adjusted according to the structural or load transfer requirements. Note that overall dimensions shall remain same as specified in this drawing.

Design & Build
SWASTIK ENTERPRISES



Client



Project Name
Biggies Burger
Kolkata Airport


Drawing Title
Counter Inside Cabinet Detail

Drawn By- Bharat	Drawing Number- BB-KA-09	Date- 15/12/2024
Checked By- Chhavi	Revision Number- R3	Scale- NTS

01

NOTES

- Dimensions to be read not scaled.
- Any discrepancy in the dimensions shall be brought to the notice of **Design Team** before execution on site.
- This drawing is for conceptualization of the fixture. Material thickness can be adjusted according to the structural or load transfer requirements. Note that overall dimensions shall remain same as specified in this drawing.

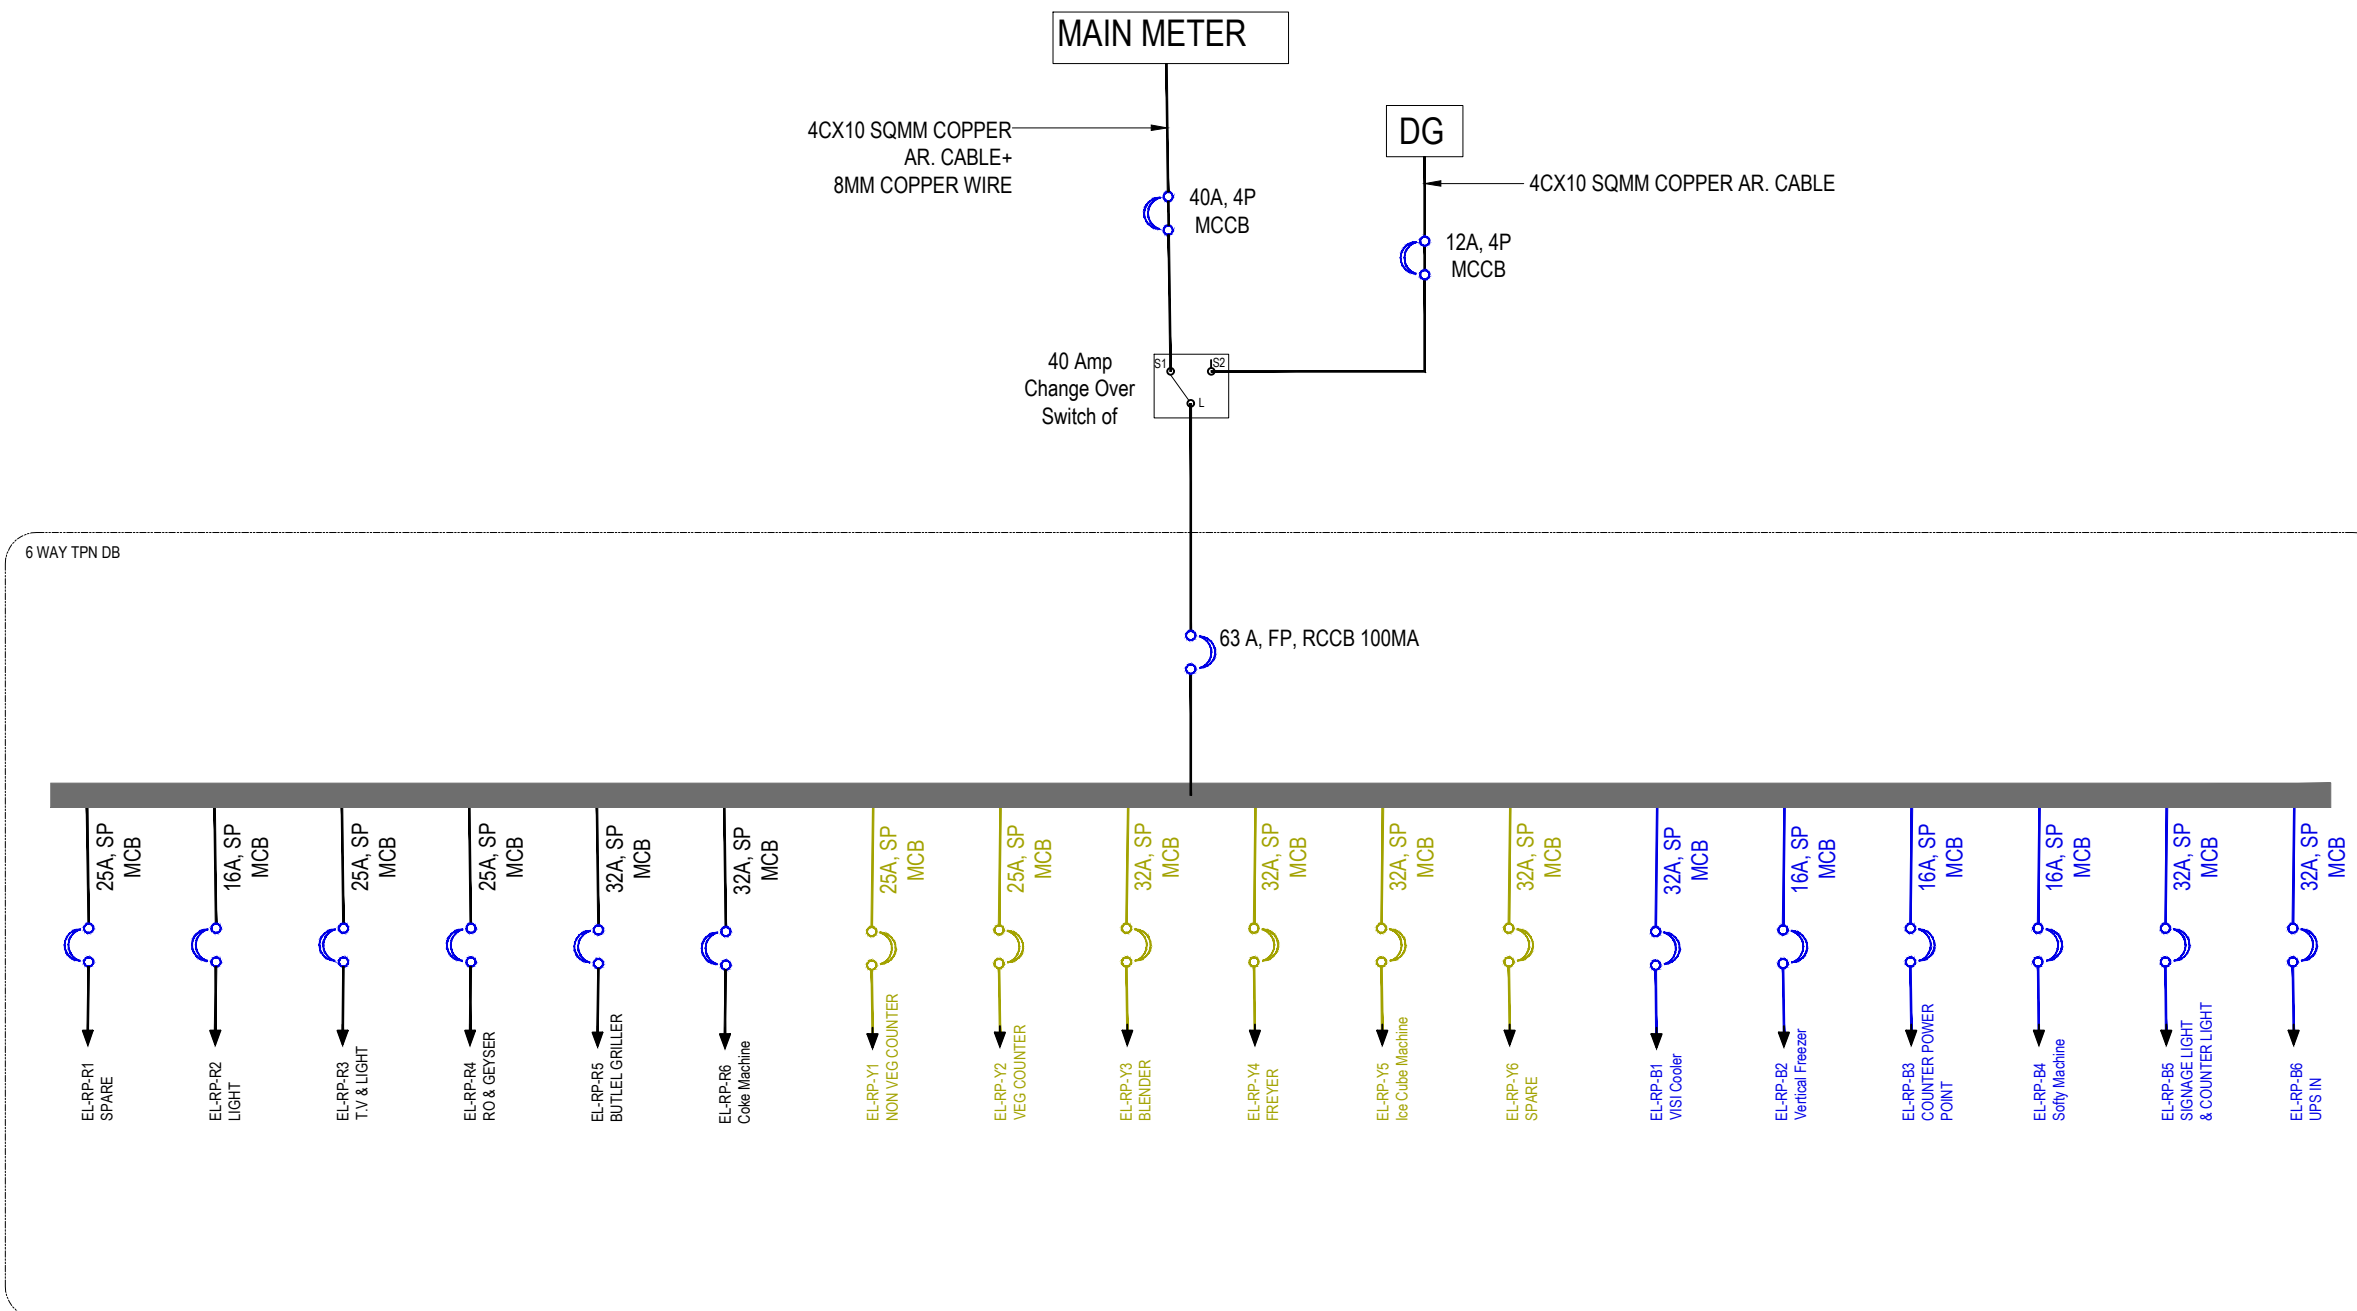

Design & Build
SWASTIK ENTERPRISES



Client



Project Name
Biggies Burger
Kolkata Airport

Drawing Title
Electrical SLD

Drawn By- Bharat	Drawing Number- BB-KA-10	Date- 15/12/2024
Checked By- Chhavi	Revision Number- R3	Scale- NTS