

T1 LOUNGE DOMESTIC / INT TERMINAL



Kempegowda
INTERNATIONAL
AIRPORT
BENGALURU

BANGALORE INTERNATIONAL AIRPORT LIMITED
KEMPEGOWDA INTERNATIONAL AIRPORT, DEVANAHALLI, BENGALURU - 560 306.

CLIENT:



Travel Food Services Pvt Ltd

Shiv Sagar Estate, A-Block, 1st floor A.B.
Road Worli, Mumbai - 400 018
INDIA.
www.travelfoodservices.com

CONCEPT DESIGNER:



INTERIOR CONSULTANT:

STAMP & SIGN



DATE

MEP CONSULTANT:

STAMP & SIGN



DATE

KEY PLAN

IMPORTANT NOTE

ALL DIMENSIONS ARE IN MM, UNLESS OTHERWISE SPECIFIED.

REVISION NO


R1

REV. NO.	DESCRIPTION	DATE
01	FOR APPROVAL	06.08.2024
02	FOR APPROVAL	05.08.2024

DESIGN A.C.	DATE	PROJECT	SCALE
DR/AM	04-05-2024	T1 LOUNGES:	
AL/MS	06-05-2024	DOMESTIC LOUNGE - BIAL,	SHEET SIZE
APPD	06-05-2024	PHASE 2, LEVEL 3	A1

DWG TITLE: PHASE-2 : DATA LAYOUT

RELEASED FOR: INFORMATION REVIEW OFC AS-BUILT

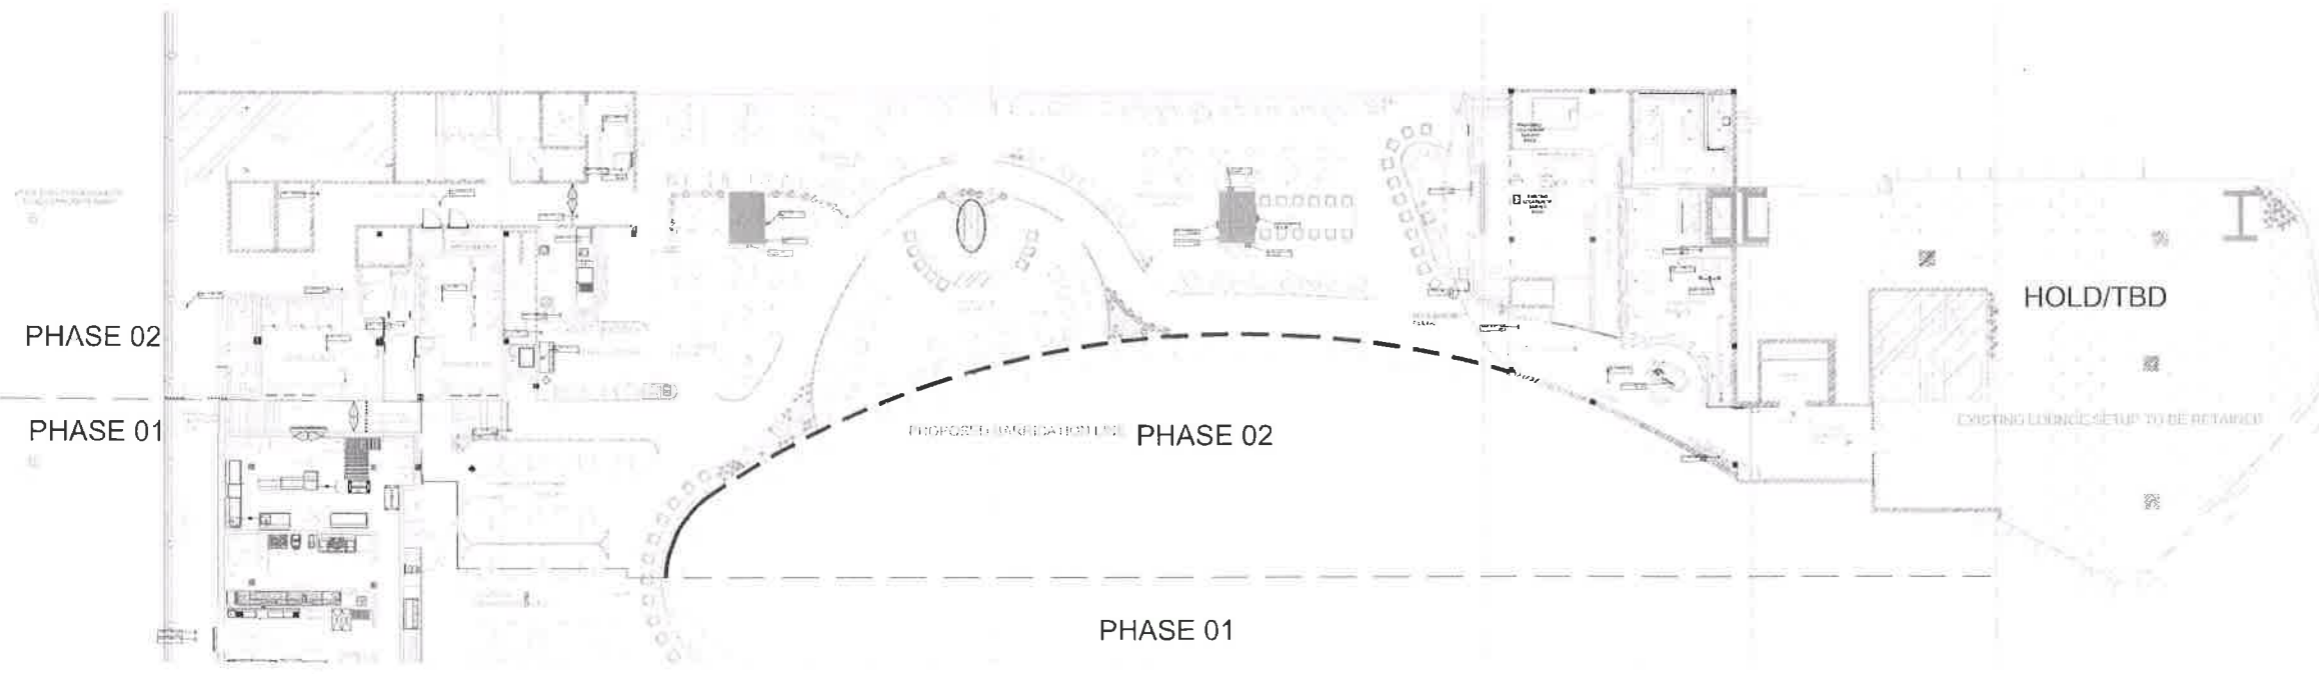

LEGEND : - DATA

•	DATA POINT FOR FIDS - 02 NOS.
•	DATA POINT FOR TV - 08 NOS. 5+1
•	DATA POINT FOR WIFI - 09 NOS.
•	DATA POINT FOR INTERACTIVE DIGITAL SCREEN - 02 NOS. ✓
•	DATA POINT FOR LECTERN - 08 NOS. 1+16 4+6+4 = 14+2 = 16 (PA) ✓
•	DATA POINT FOR LIVE KITCHEN - 04 NOS. ✓
•	DATA POINT FOR BAR - 04 NOS. ✓
•	DATA POINT FOR RECEPTION - 06 NOS. SPA 4 ✓
•	DATA POINT FOR RETAIL SHOP - 00 NOS.
•	DATA POINT FOR CCTV - 14 NOS. ✓

• **TEA GARDEN - 1+1**
63

7/8/24

P. Jimmy
7/8/24