


T1 LOUNGE DOMESTIC / INT TERMINAL



BANGALORE INTERNATIONAL AIRPORT LIMITED
KEMPEGOWDA INTERNATIONAL AIRPORT, DEVANAHALLI, BENGALURU - 560 300.

CLIENT:

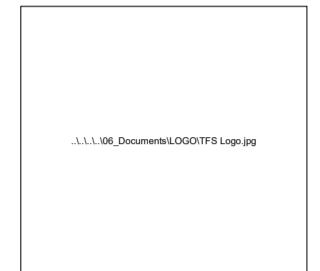

Travel Food Services Pvt Ltd

Shiv Sagar Estate, A-Block, 1st floor A.B.
Road Worli, Mumbai - 400 018
INDIA.
www.travelfoodservices.com

CONCEPT DESIGNER:



INTERIOR CONSULTANT:



STAMP & SIGN

DATE

MEP CONSULTANT :



STAMP & SIGN

DATE

665, Millennium, Veer Savarkar Marg,
Dadar (W), Mumbai - 400 028.
nimish.shah@mepTekconsultants.com

KEY PLAN

IMPORTANT NOTE

ALL DIMENSIONS ARE IN MM, UNLESS OTHERWISE SPECIFIED.

REVISION NO


R0

REV. NO.	DESCRIPTION	DATE
00	GFC	05.06.2024

NAME	DATE	PROJECT	SCALE
DESIGN: K.C.	05-06-2024	T1 LOUNGES:	
DRAWN: NIKHIL	05-06-2024	DOMESTIC LOUNGE - BIAL,	SHEET SIZE
AUTHR: MEPTTEK	05-06-2024	PHASE 2, LEVEL 3	A1
APPD:			

DWG TITLE :
PHASE-2 : DATA LAYOUT

RELEASED FOR: INFORMATION REVIEW GFC AS-BUILT

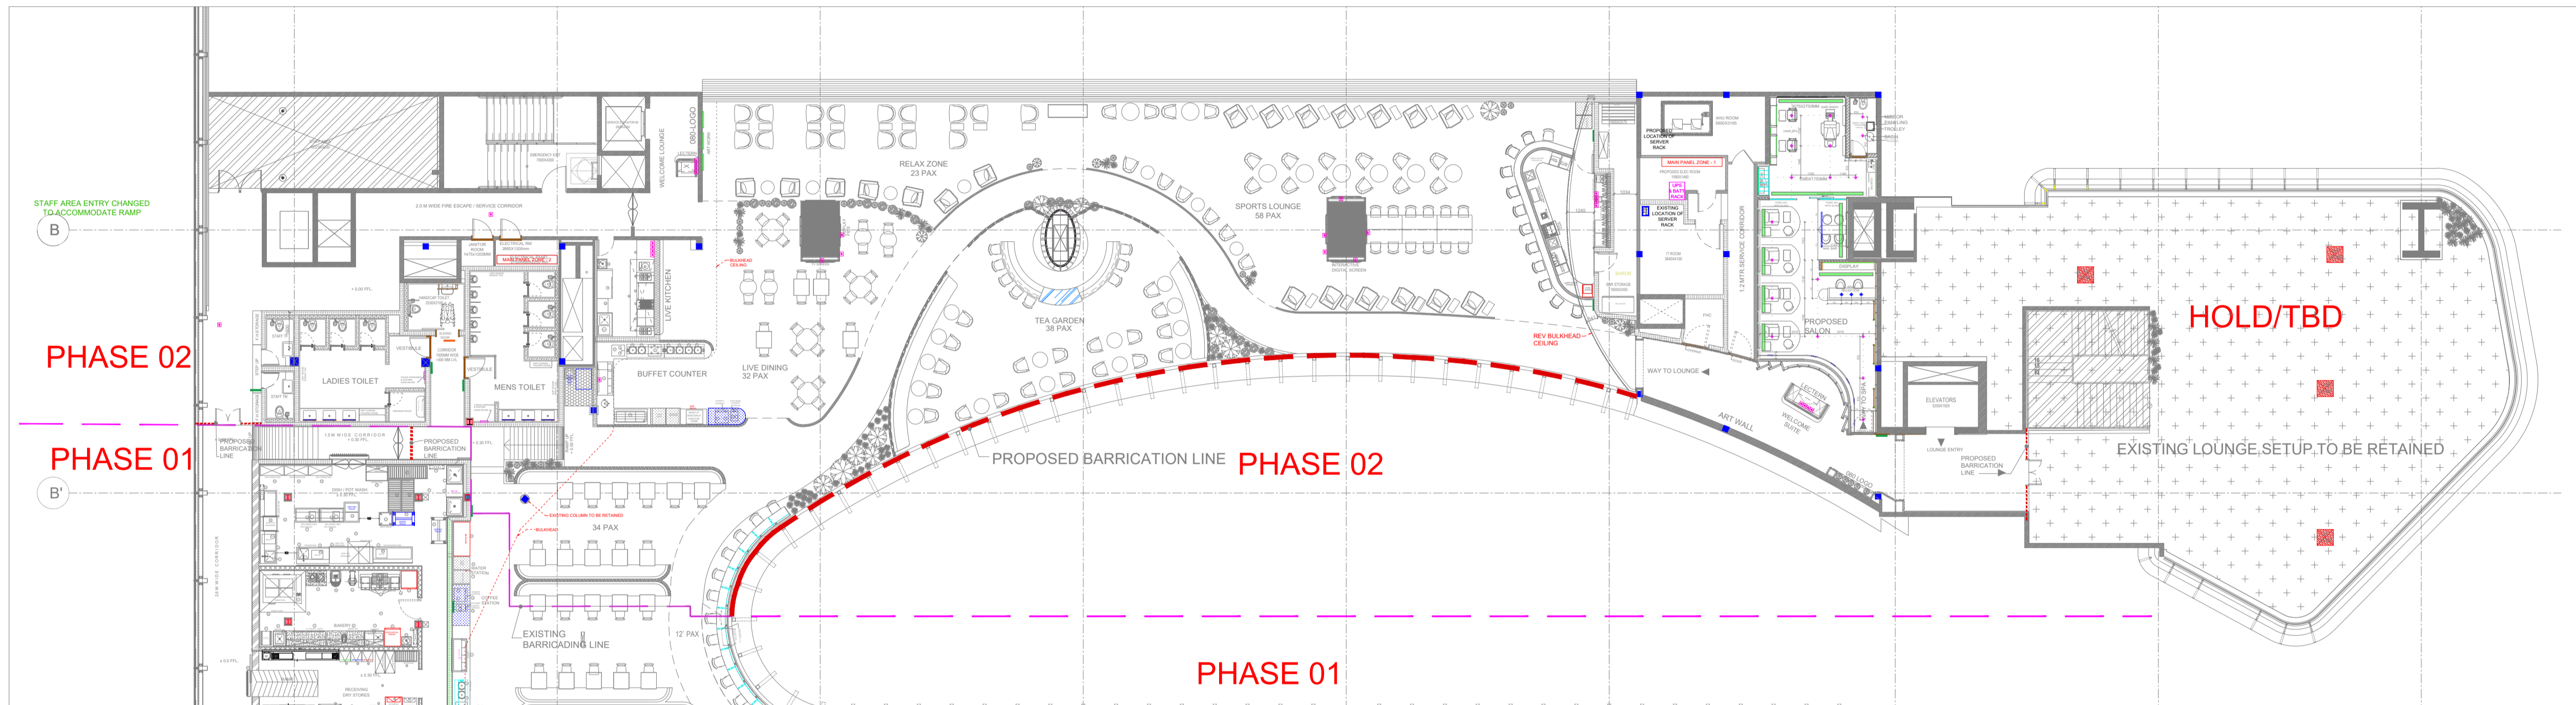

LEGEND :- DATA

	DATA POINT FOR FIDS - 02 NOS.
	DATA POINT FOR TV - 04 NOS.
	DATA POINT FOR WIFI - 04 NOS.
	DATA POINT FOR INTERACTIVE DIGITAL SCREEN - 01 NOS.
	DATA POINT FOR LECTERN - 08 NOS.
	DATA POINT FOR LIVE KITCHEN - 04 NOS.
	DATA POINT FOR BAR - 04 NOS.
	DATA POINT FOR EGATE - 00 NOS.
	DATA POINT FOR RETAIL SHOP - 00 NOS.