


INHOUSE DESIGN

COLD STORAGE @ GUWAHATI

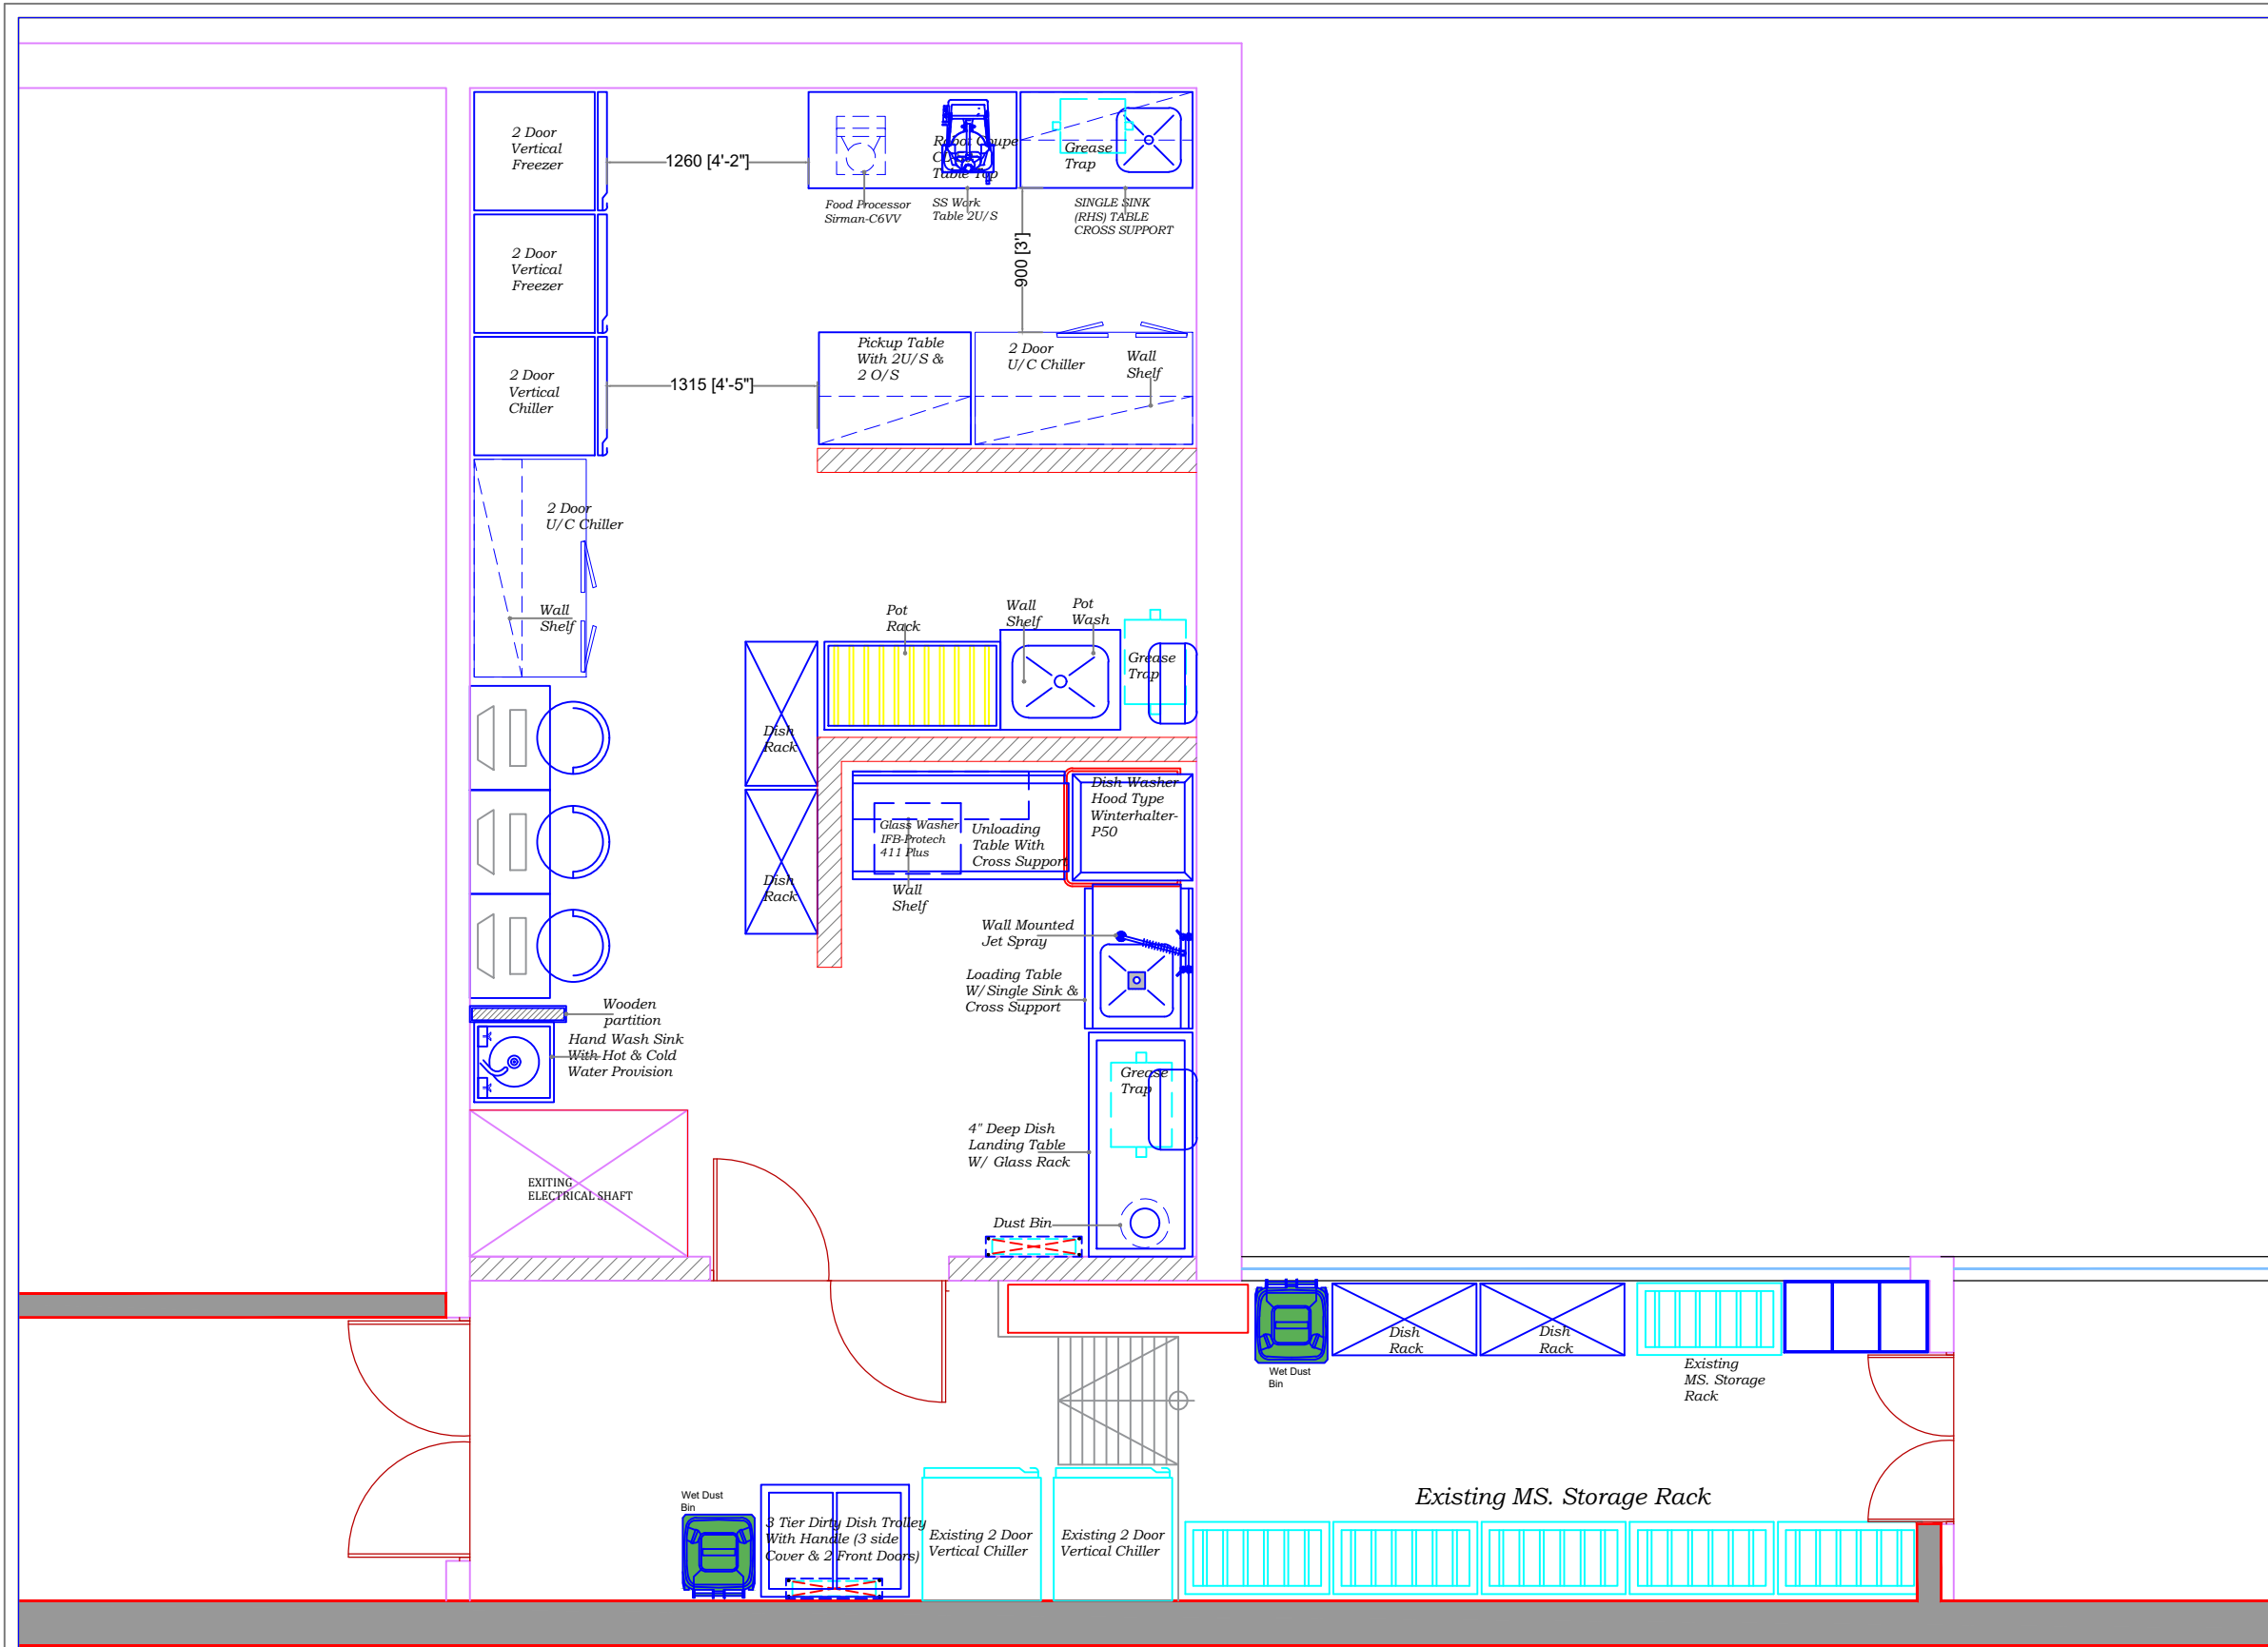


PROJECT	LOCATION	DRAWN BY	DATE	CHK BY	DATE	REVISION No.	FINAL APPROVED	DRAWING	DRAWING NAME	SHEET NUMBER
COLD STORAGE	GUWAHATI	FAHEEM	23-10-09			R1	DATE	GFC DRAWING	FURNITURE LAYOUT	01 OF 06
		DWG.No.		SCALE		REVISION DATE :				
		----		NTS.		23-10-17				



Travel Food Services

INHOUSE DESIGN

**COLD STORAGE
@
GUWAHATI**

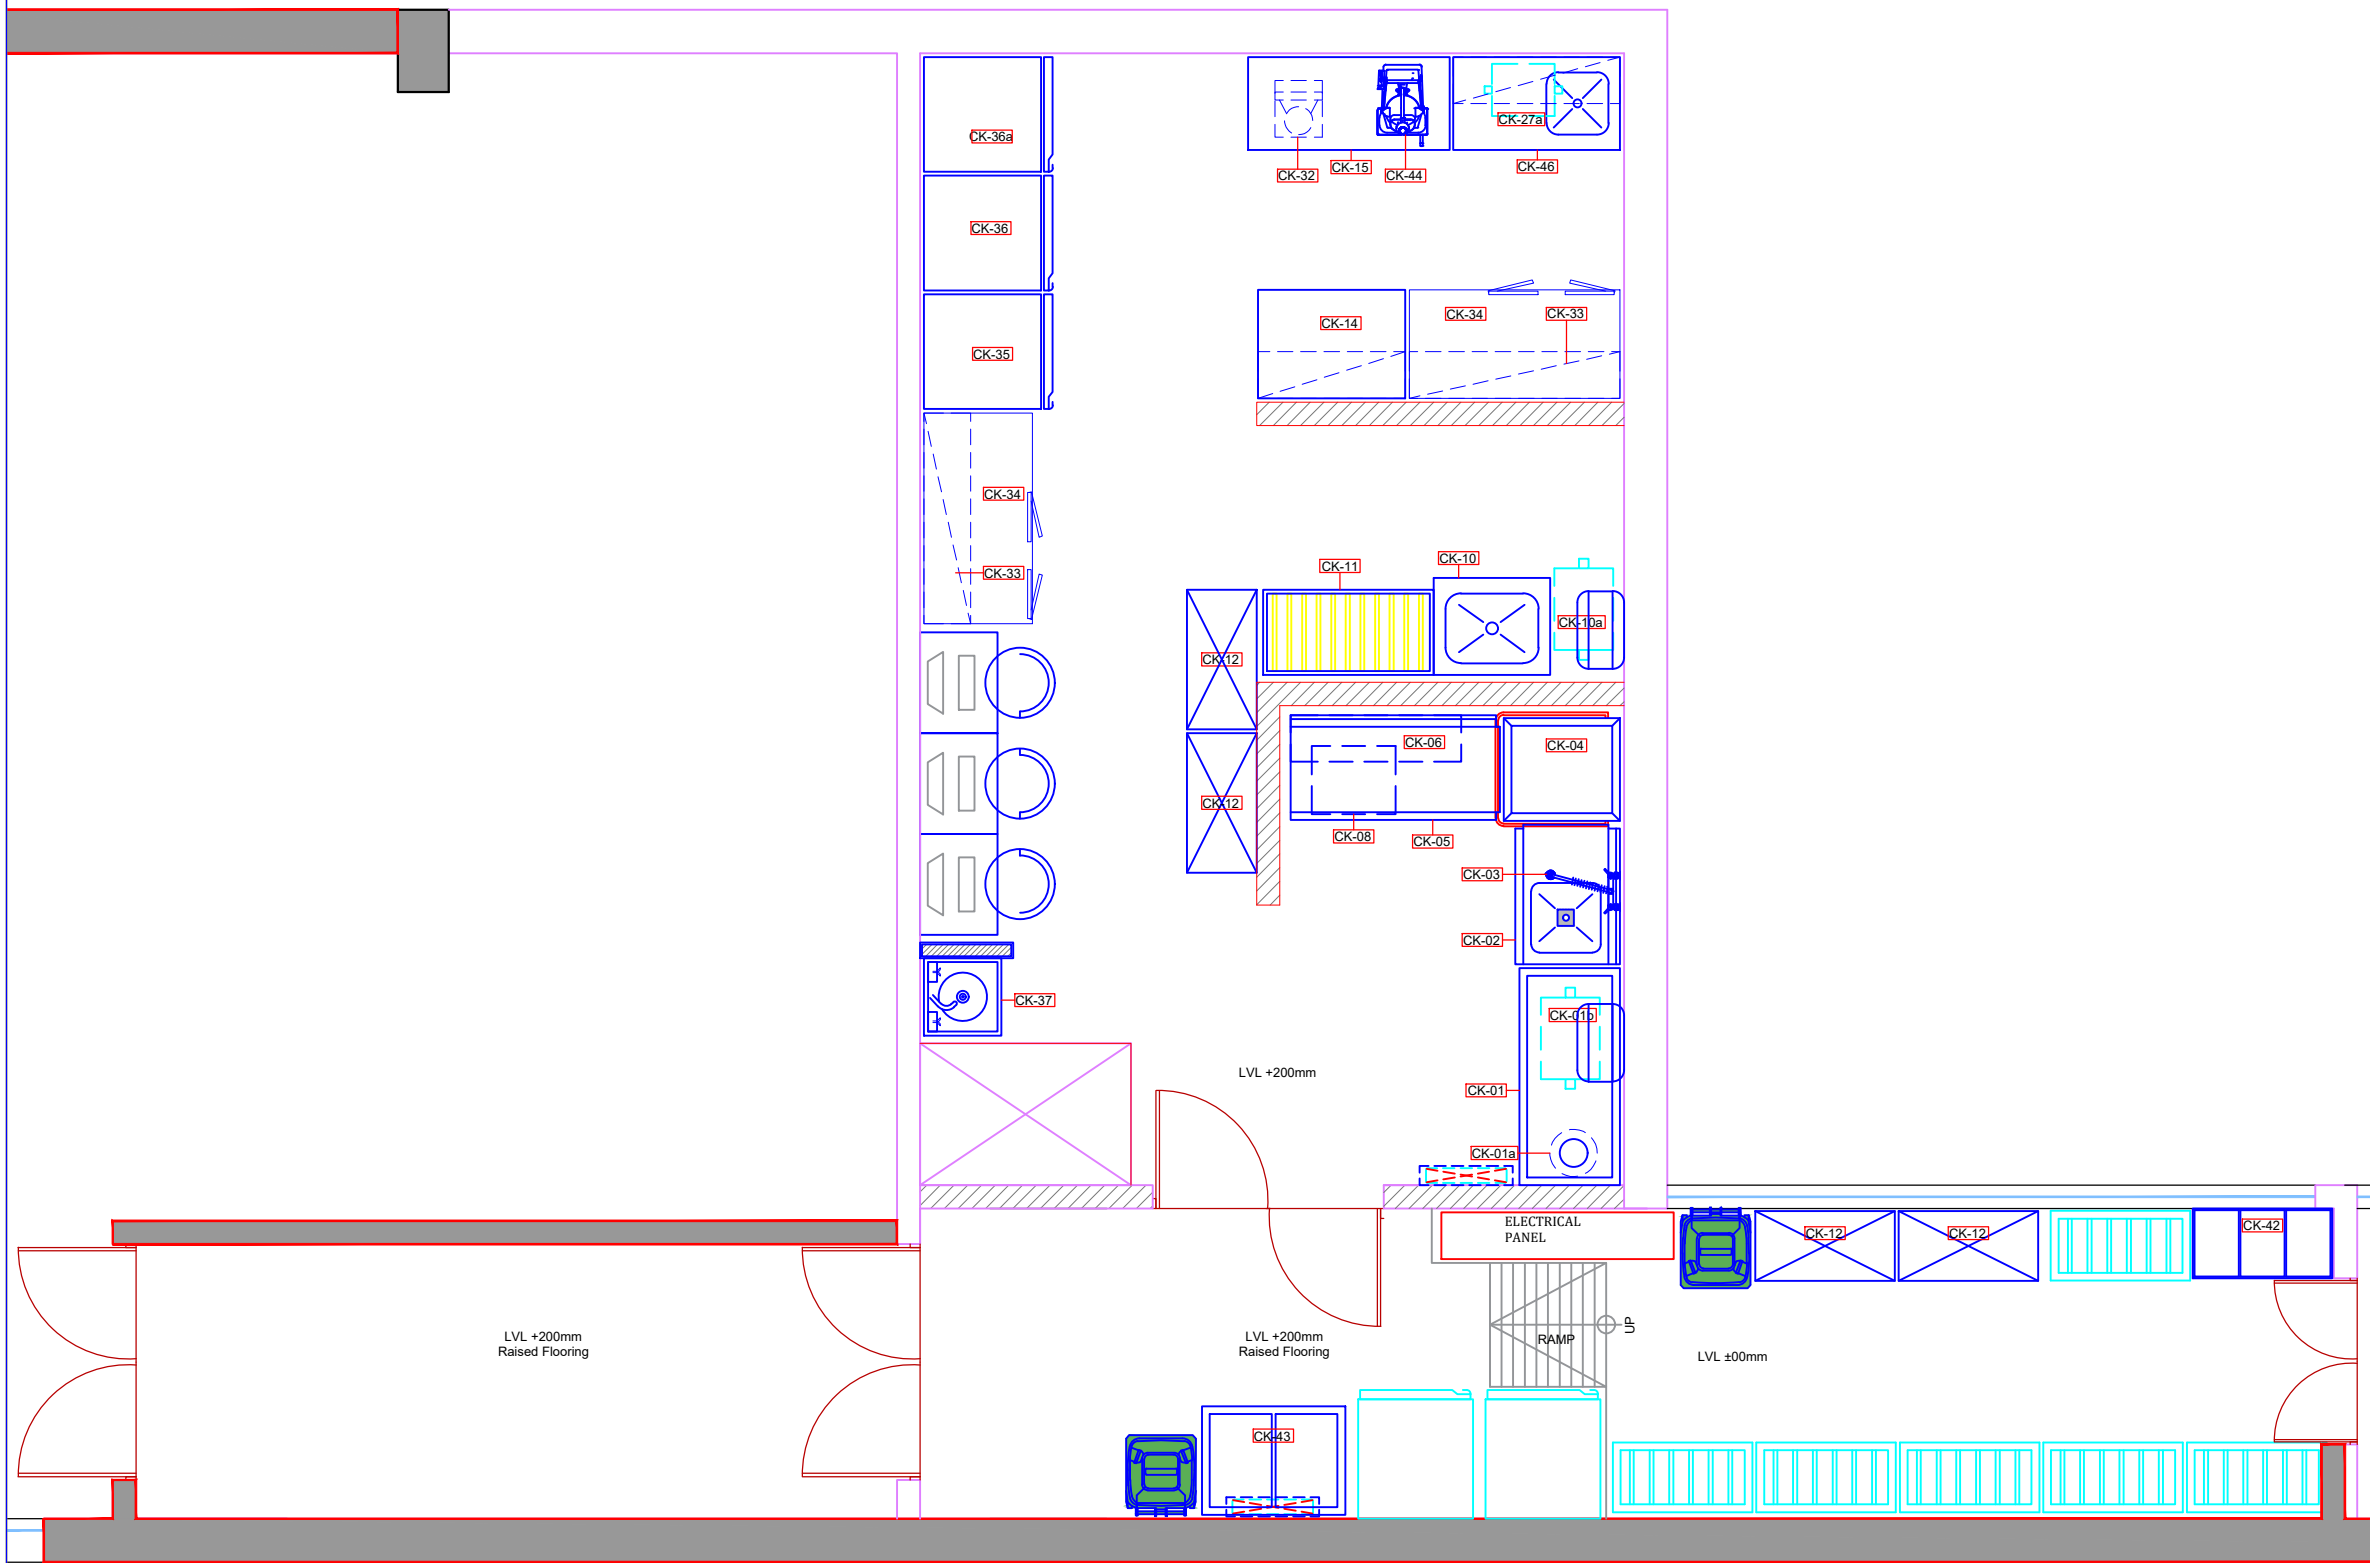


PROJECT	LOCATION	DRAWN BY	DATE	CHK BY	DATE	REVISION No.	FINAL APPROVED	DRAWING	DRAWING NAME	SHEET NUMBER
COLD STORAGE	GUWAHATI	FAHEEM	23-10-09			R1	DATE	GFC DRAWING	FURNITURE LAYOUT	02 OF 06
		DWG.No.		SCALE		REVISION DATE :				
		----		NTS.		2023-10-17				



Travel Food Services

INHOUSE DESIGN


**COLD STORAGE
@
GUWAHATI**

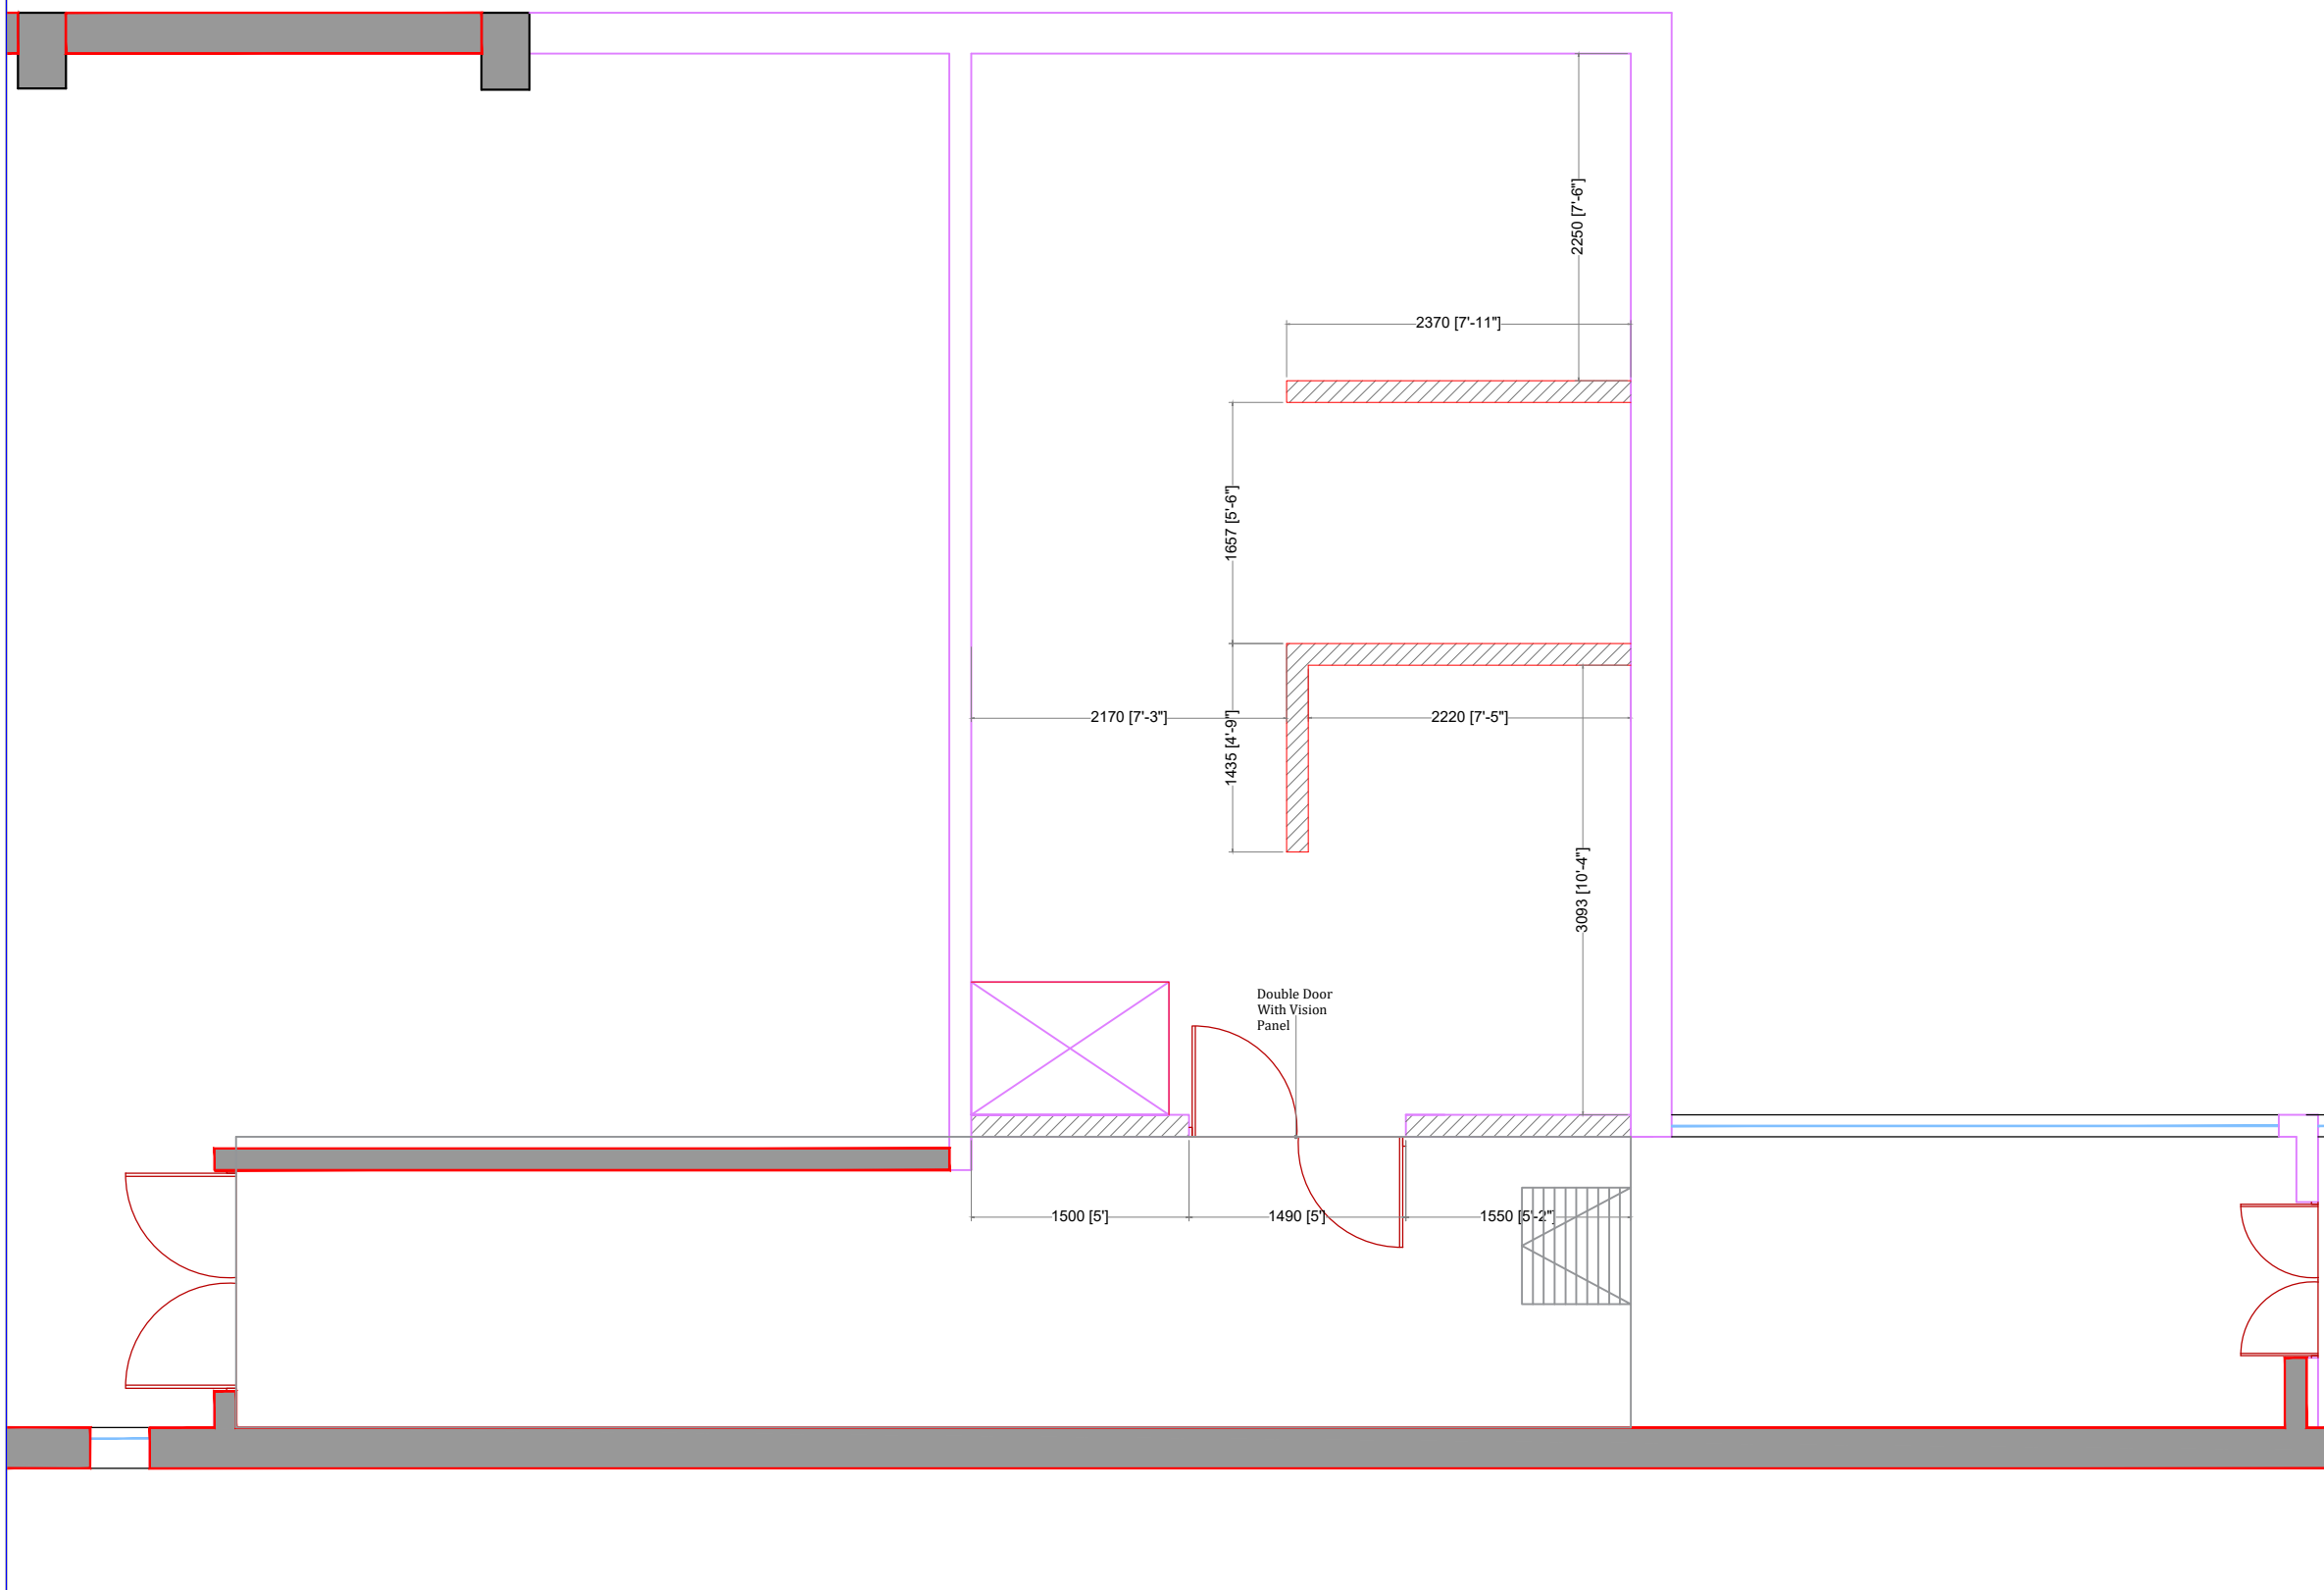
 
 
 
 





PROJECT	LOCATION	DRAWN BY	DATE	CHK BY	DATE	REVISION No.	FINAL APPROVED	DRAWING	DRAWING NAME	SHEET NUMBER
COLD STORAGE	GUWAHATI	FAHEEM	23-10-09			R1				
		DWG.No.		SCALE		REVISION DATE :	DATE	GFC DRAWING	CIVIL LAYOUT	06 OF 07
		----		NTS.		2023-10-17				

INHOUSE DESIGN

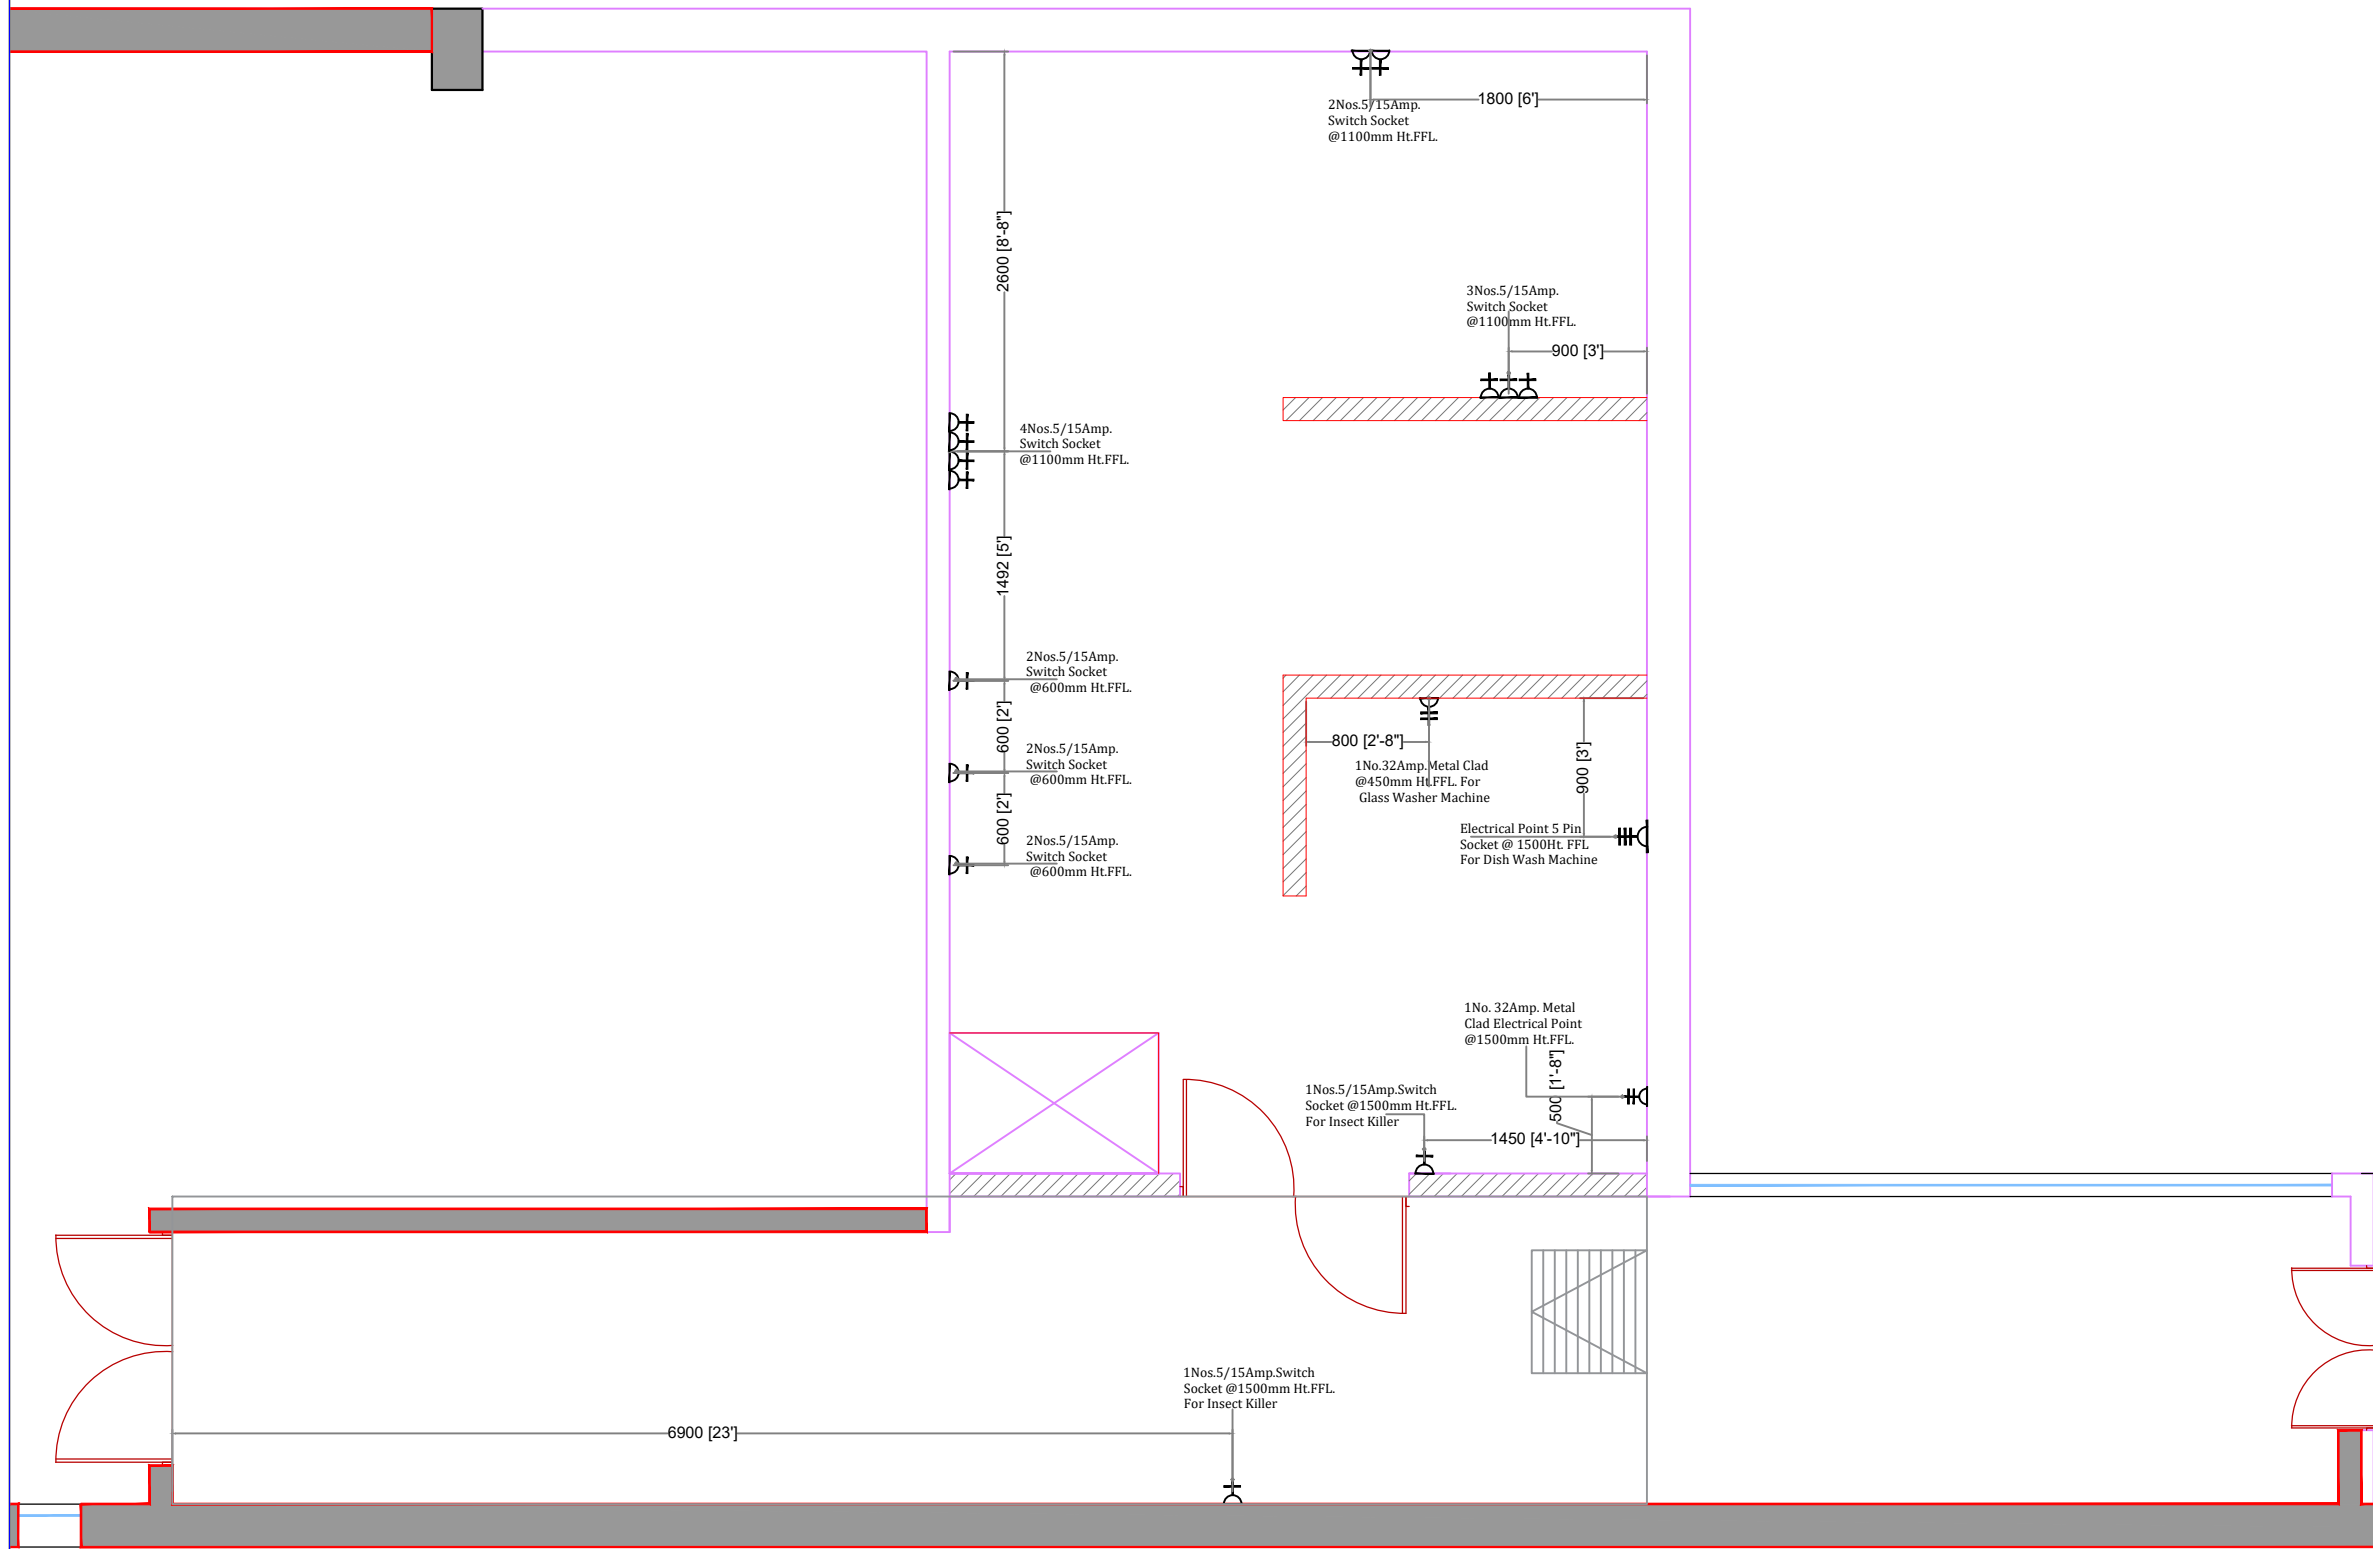**COLD STORAGE
@
GUWAHATI**




ELECTRICAL LEGEND	
	5 AMP PLUG POINT
	5/15 AMP POWER PLUG POINT (MODULAR SWITCH & SOCKET)
	20/32 AMP METAL CLAD WITH 20 AMP SP MCB & PLUG TOP
	3 PHASE SUPPLY
	COMPUTER POINT
	TELEPHONE POINT
	DATA CABLE POINT FOR KOT PRINTER
	INTERNET

PROJECT	LOCATION	DRAWN BY	DATE	CHK BY	DATE	REVISION No.	FINAL APPROVED	DRAWING	DRAWING NAME	SHEET NUMBER	
COLD STORAGE	GUWAHATI	FAHEEM	23-10-09			R1					
		DWG.No.		SCALE		REVISION DATE :	DATE		GFC DRAWING	ELECTRIC LAYOUT	05 OF 07
		----		NTS.		2023-10-17					

INHOUSE DESIGN

COLD STORAGE @ GUWAHATI

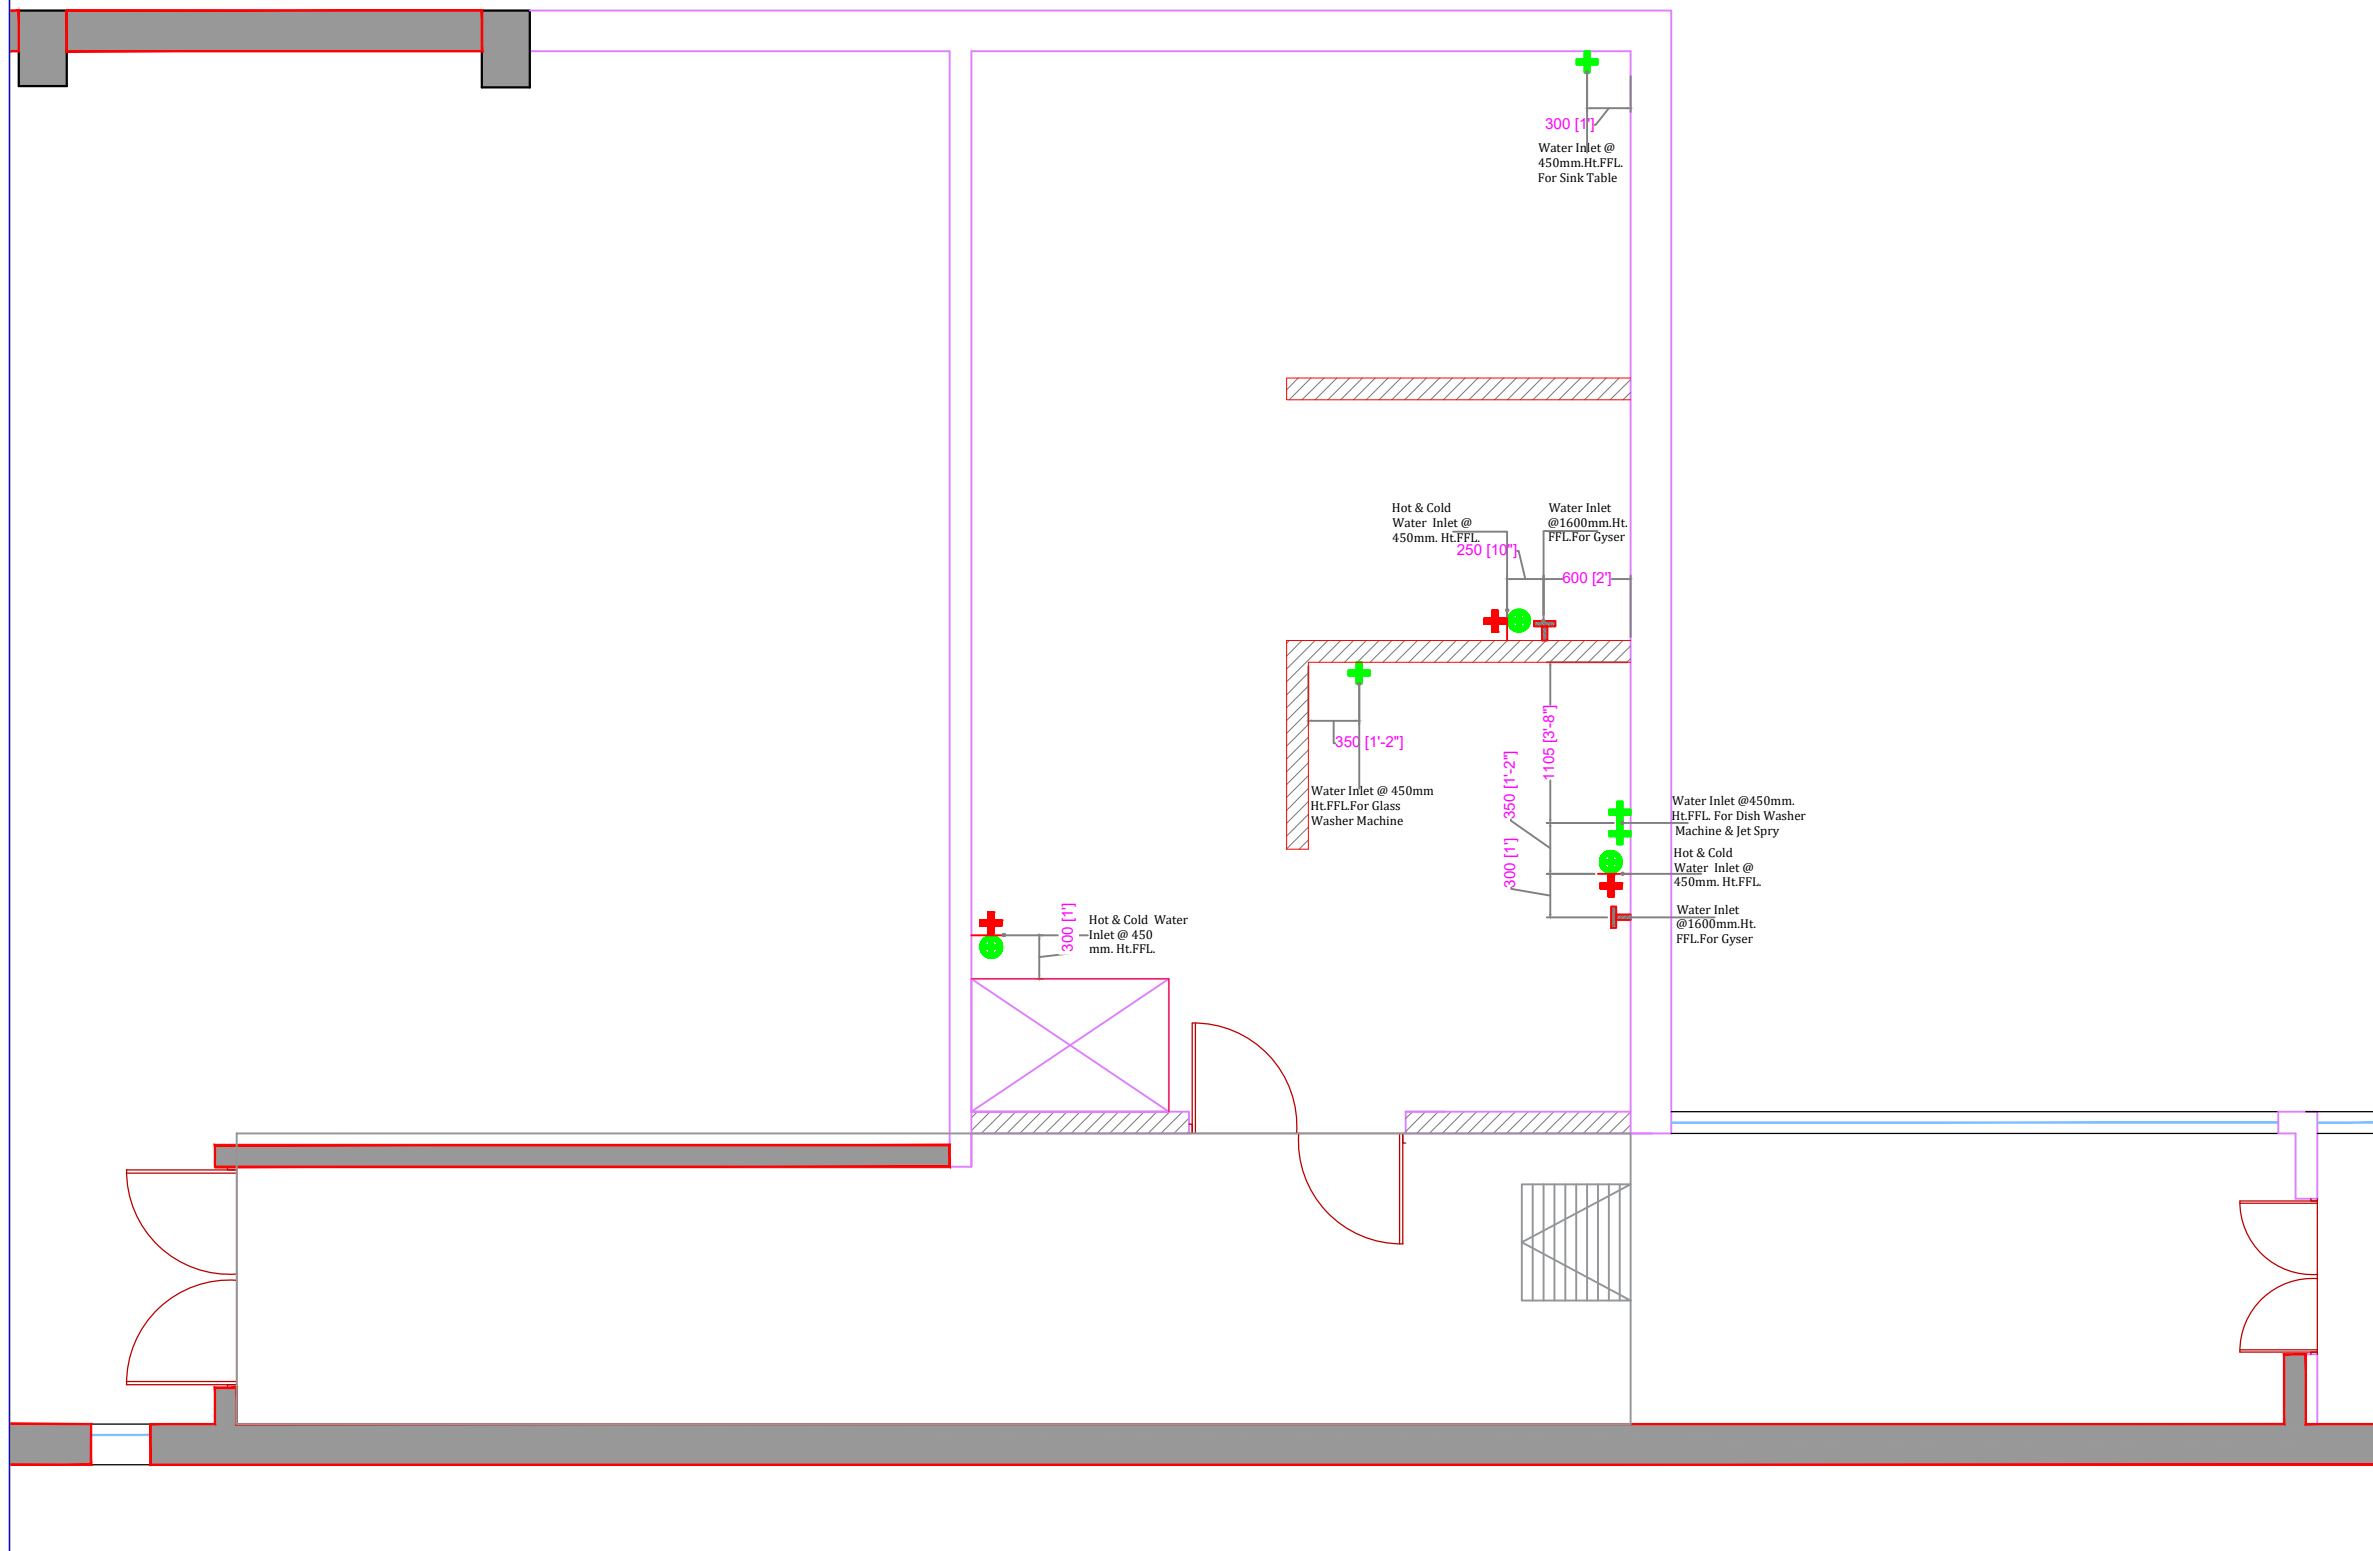


Plumbing Legends	
	12mm Dia. Cold Water Inlet
	12mm Dia. Cold Water & Hot Water Inlet
	RO Water Inlet
	Stop Angular Point

PROJECT	LOCATION	DRAWN BY	DATE	CHK BY	DATE	REVISION No.	FINAL APPROVED	DRAWING	DRAWING NAME	SHEET NUMBER
COLD STORAGE	GUWAHATI	FAHEEM	23-10-09			R1				
		DWG.No.		SCALE		REVISION DATE :	DATE	GFC DRAWING	PLUMBING LAYOUT	03 OF 07
		----		NTS.		2023-10-17				



INHOUSE DESIGN

**COLD STORAGE
@
GUWAHATI**

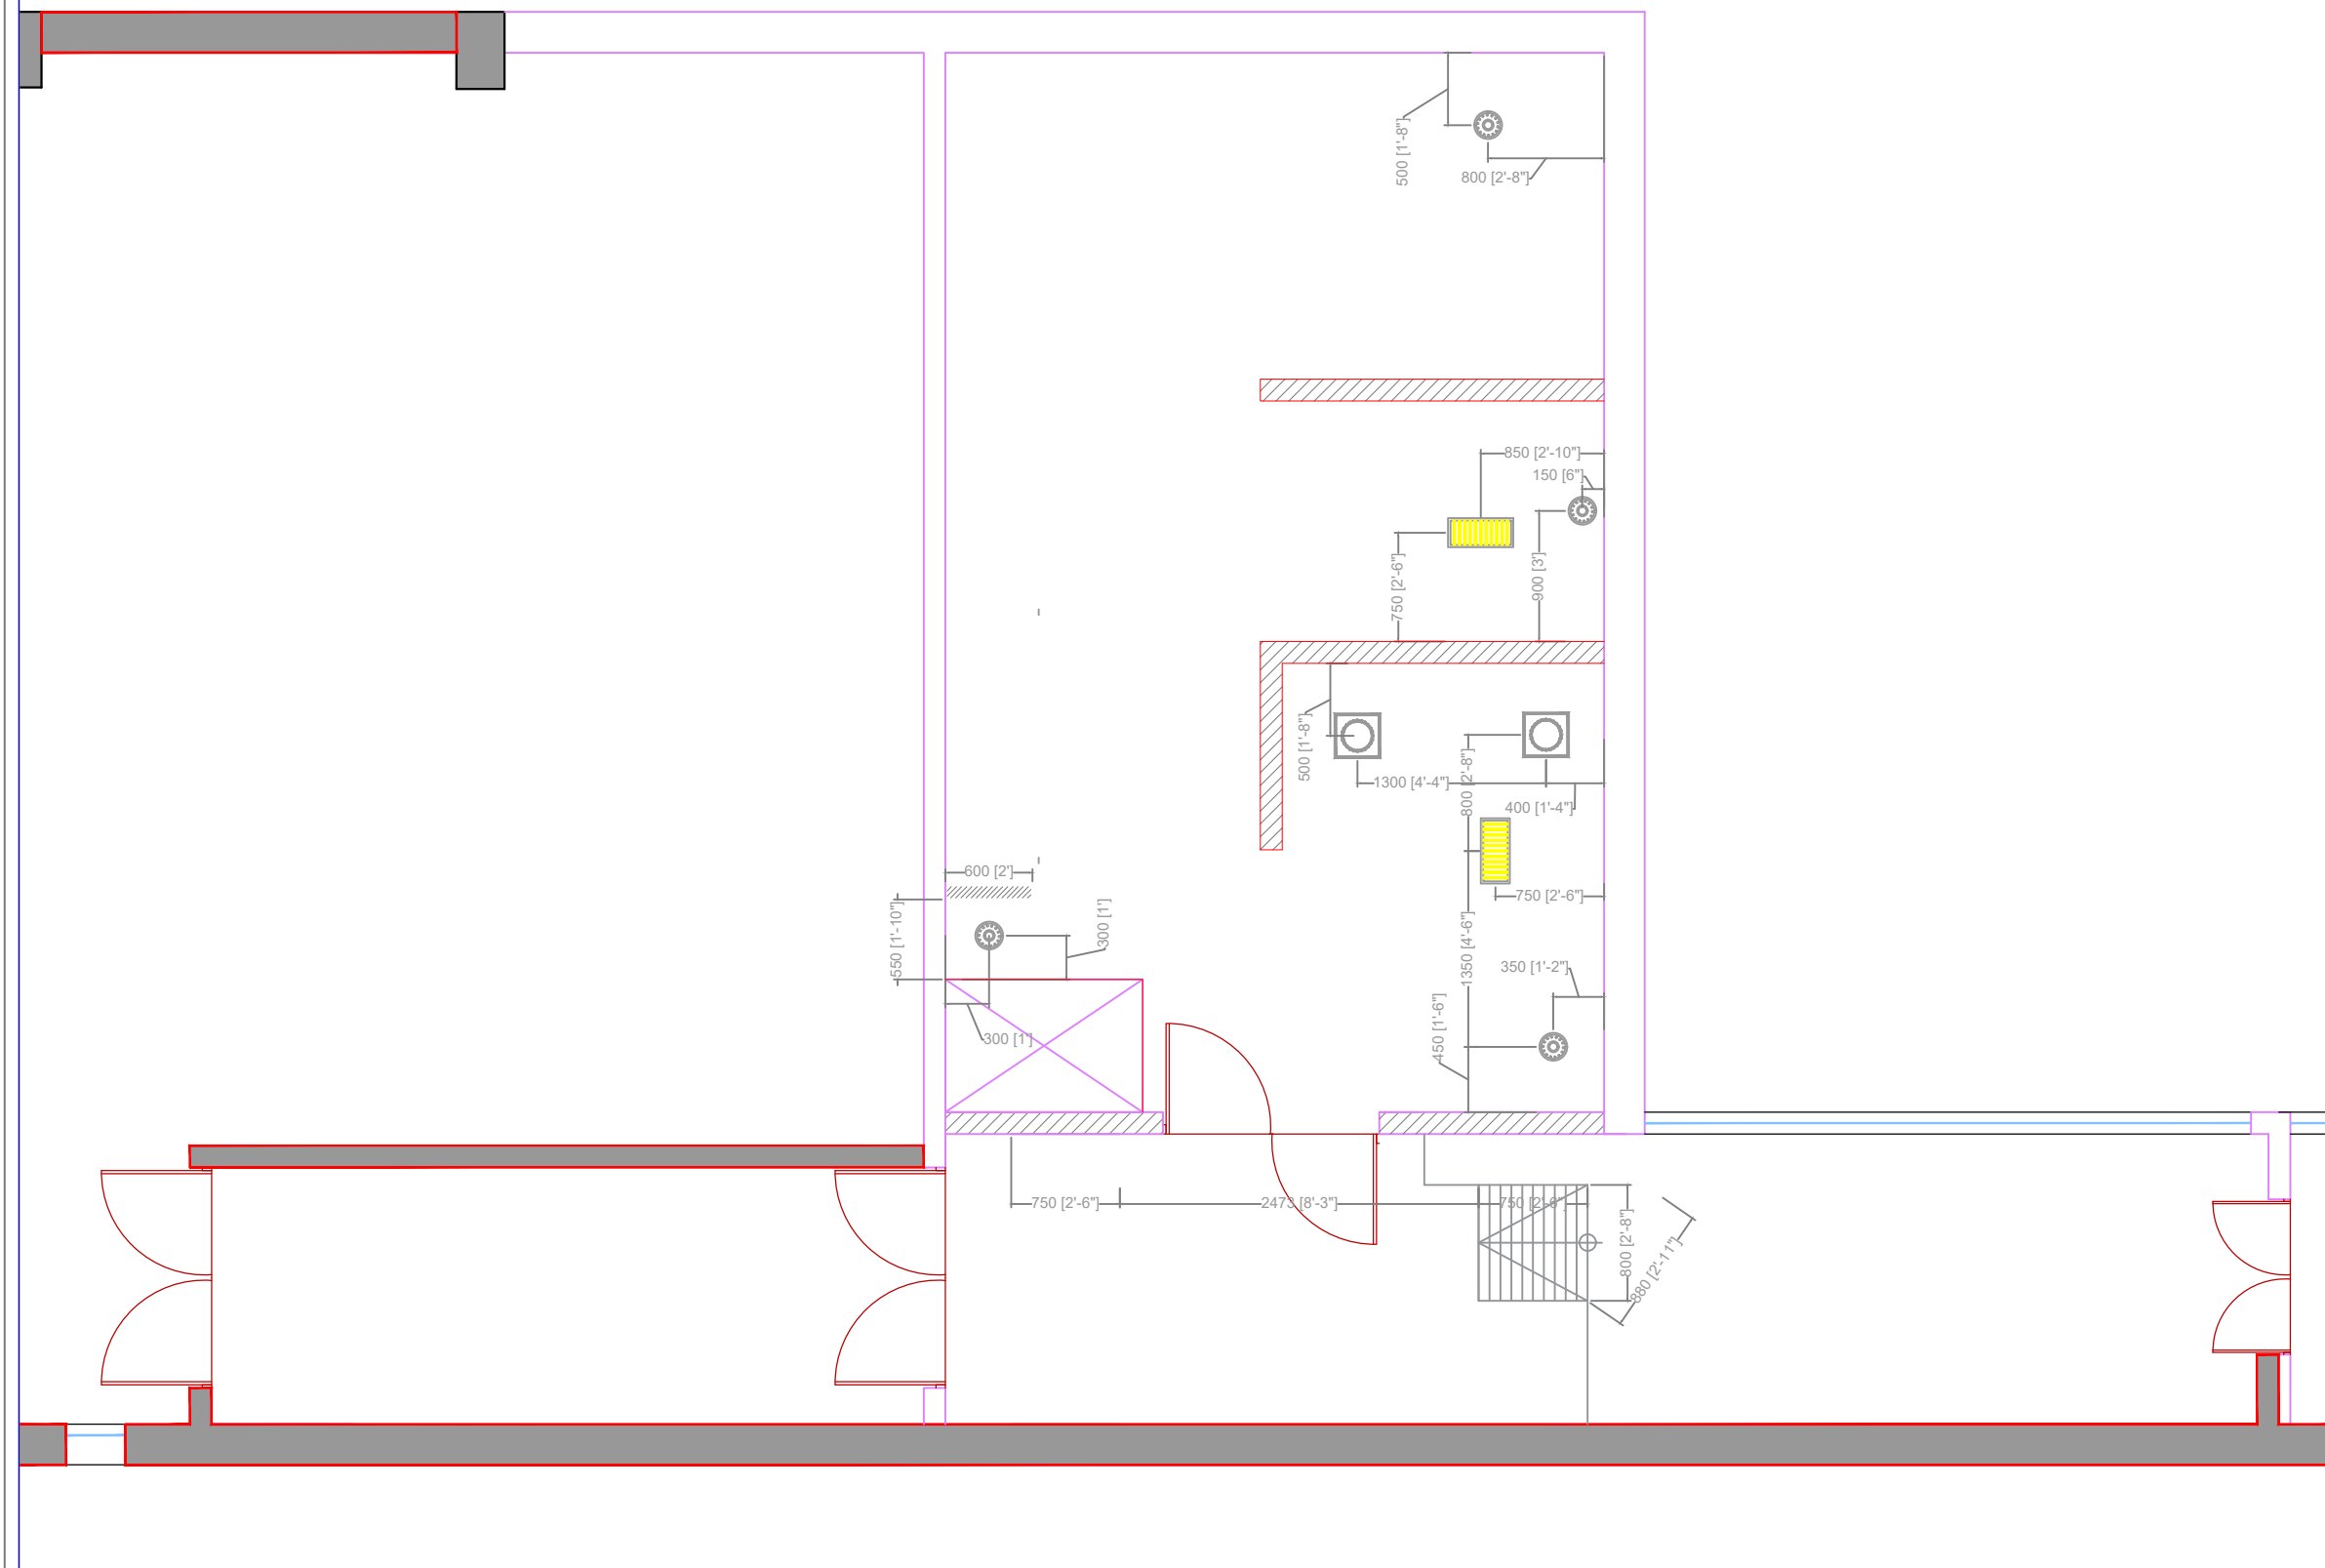

	=450x200 x 25mm Floor Grating
	=300x300 x 25mm Chamber Grating
	100mm Dia. Nani Trap On Floor.

PROJECT	LOCATION	DRAWN BY	DATE	CHK BY	DATE	REVISION No.	FINAL APPROVED	DRAWING	DRAWING NAME	SHEET NUMBER
COLD STORAGE	GUWAHATI	FAHEEM	23-10-09			R1				
		DWG.No.		SCALE		REVISION DATE :	DATE			
		----		NTS.		2023-10-17		GFC DRAWING	DRAINAGE LAYOUT	04 OF 07