

DESIGNERS : _____ Authorized Signature : _____

DRAWING SUPERVISORS : _____

PROJECT NUMBER : _____ S-00

PROJECT NAME : _____

NIC ICE CREAM -
 LUCKNOW AIRPORT
 TERMINAL 3

DRAWING TITLE :

FURNITURE LINEOUT

ISSUED / REVISION :

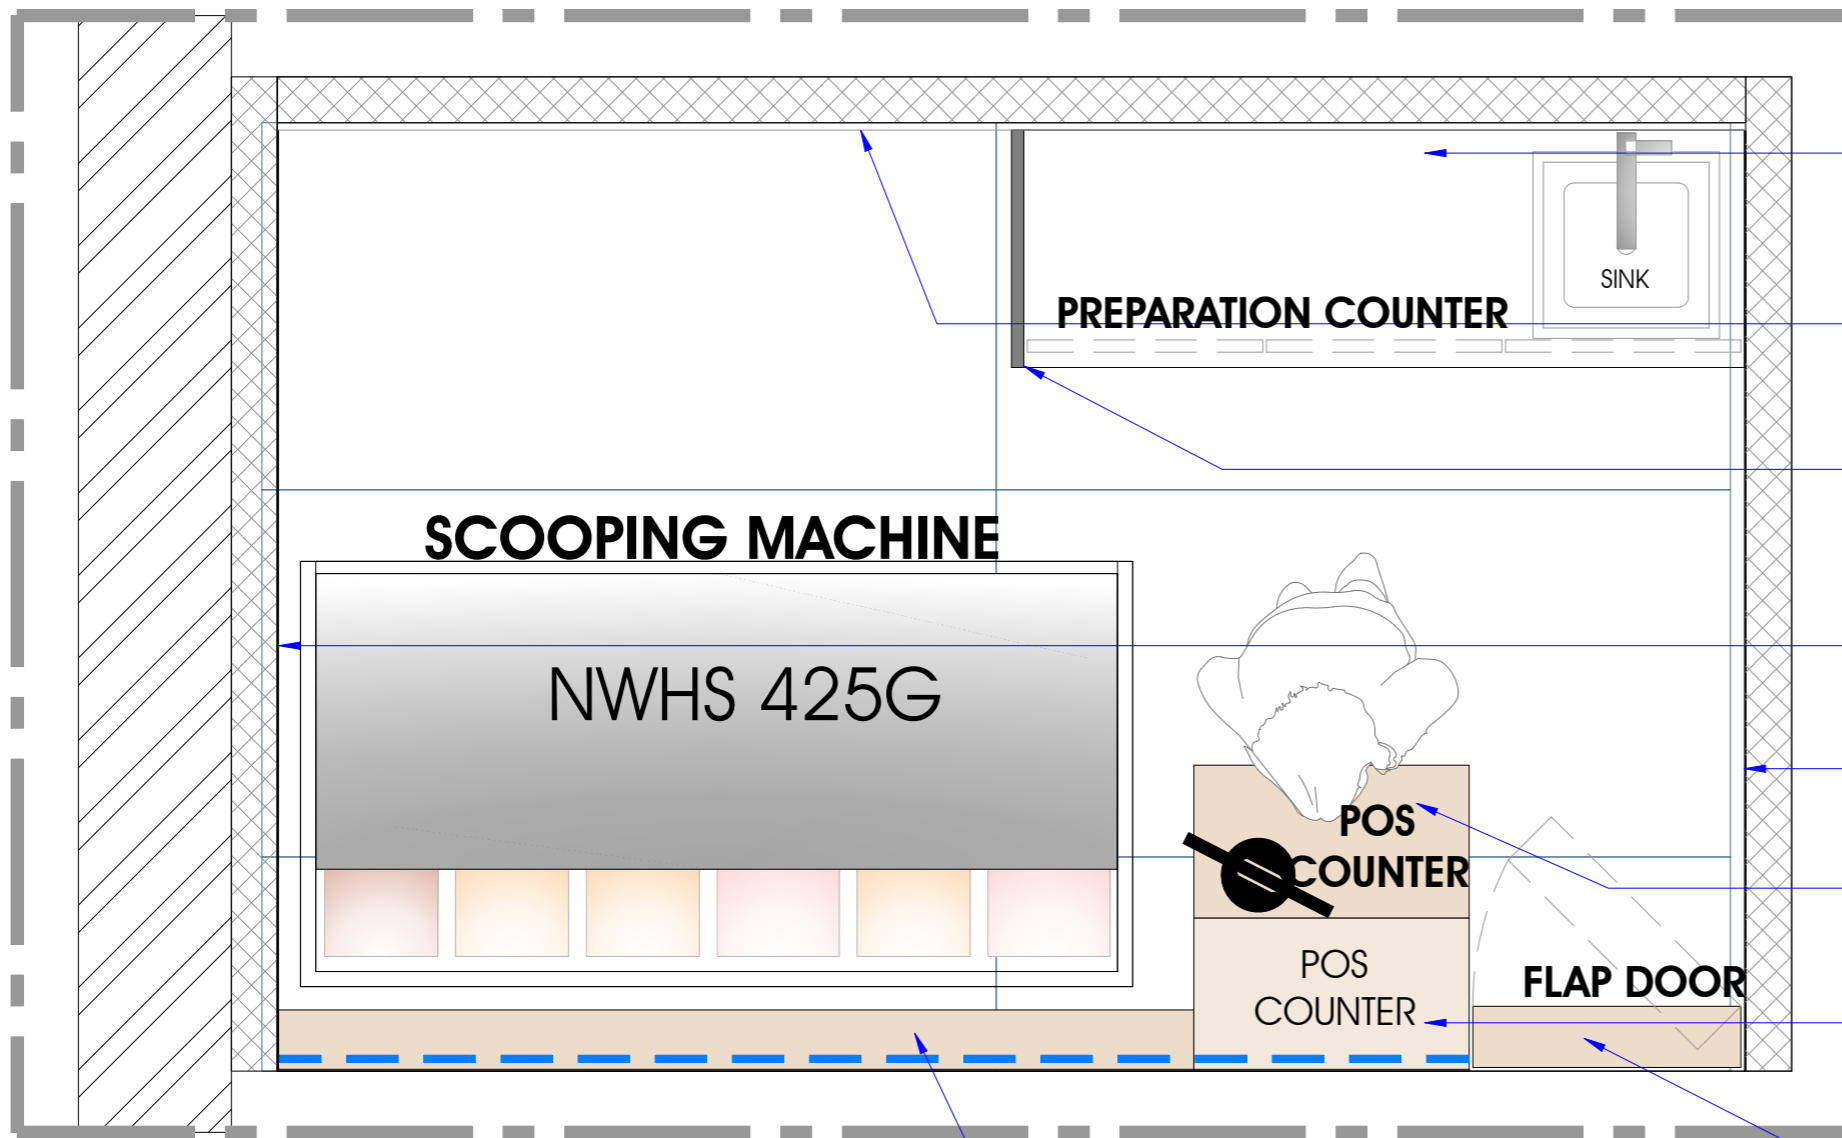
NO.	DATE	REMARKS
1.		
2.		
3.		
4.		
5.		

DRAWN BY : JAY P. DRAWING NO. S - 01

CHECKED BY : AMITA C.

SCALE : N T S DATE : 03-04-2024

AREA : AREA - 42 SQFT NORTH :



COUNTER TOP FINISHED IN GR-01

EXISTING PARTITION PARTLY FINISHED IN TL-01 & PARTLY FINISHED IN M-01

VERTICAL PARTITION GR-01

EXISTING PARTITION FINISHED IN PT-01

EXISTING PARTITION FINISHED IN PT-01

POS COUNTER TOP FINISHED IN L-01

POS COUNTER TOP FINISHED IN TL-01

FLAP DOOR RECESSED 10 MM FINISHED IN L-01

LOW HEIGHT PARTITION FACIA, TOP & SKIRTING FINISHED IN TL-01 &

BACKSIDE FINISHED IN L-01

FURNITURE LAYOUT

FINISH LEGEND

IMAGE	INDICATION	DESCRIPTION	IMAGE	INDICATION	DESCRIPTION
	TL-01	COMPANY -NEXION SERIES -ENDLESS BIANCO SIZE - 1200MM X600MM		L-01	COMPANY - GREENLAM LAMINATES SERIES - 2020_2022 COLLECTION CODE - 133 SUD MOON STONE
	PT-01	COMPANY - ASIAN PAINT CODE - 0684 Crusade-N AP Y 0914-0714M		GR-01	BLACK GRANITE
	M-01	5/6MM GREY TINTED MIRROR (EDGE TO BE MACHINE POLISHED)			

DESIGNERS : _____ Authorized Signature : _____

DRAWING SUPERVISORS : _____

PROJECT NUMBER : _____ S-00

PROJECT NAME : _____

NIC ICE CREAM -
LUCKNOW AIRPORT
TERMINAL 3

DRAWING TITLE :

SECTIONAL PLAN


ISSUED / REVISION :

NO.	DATE	REMARKS
1.		
2.		
3.		
4.		
5.		

DRAWN BY : JAY P.
DRAWING NO. S - 02
CHECKED BY : AMITA C.


SCALE : N T S
DATE : 03-04-2024

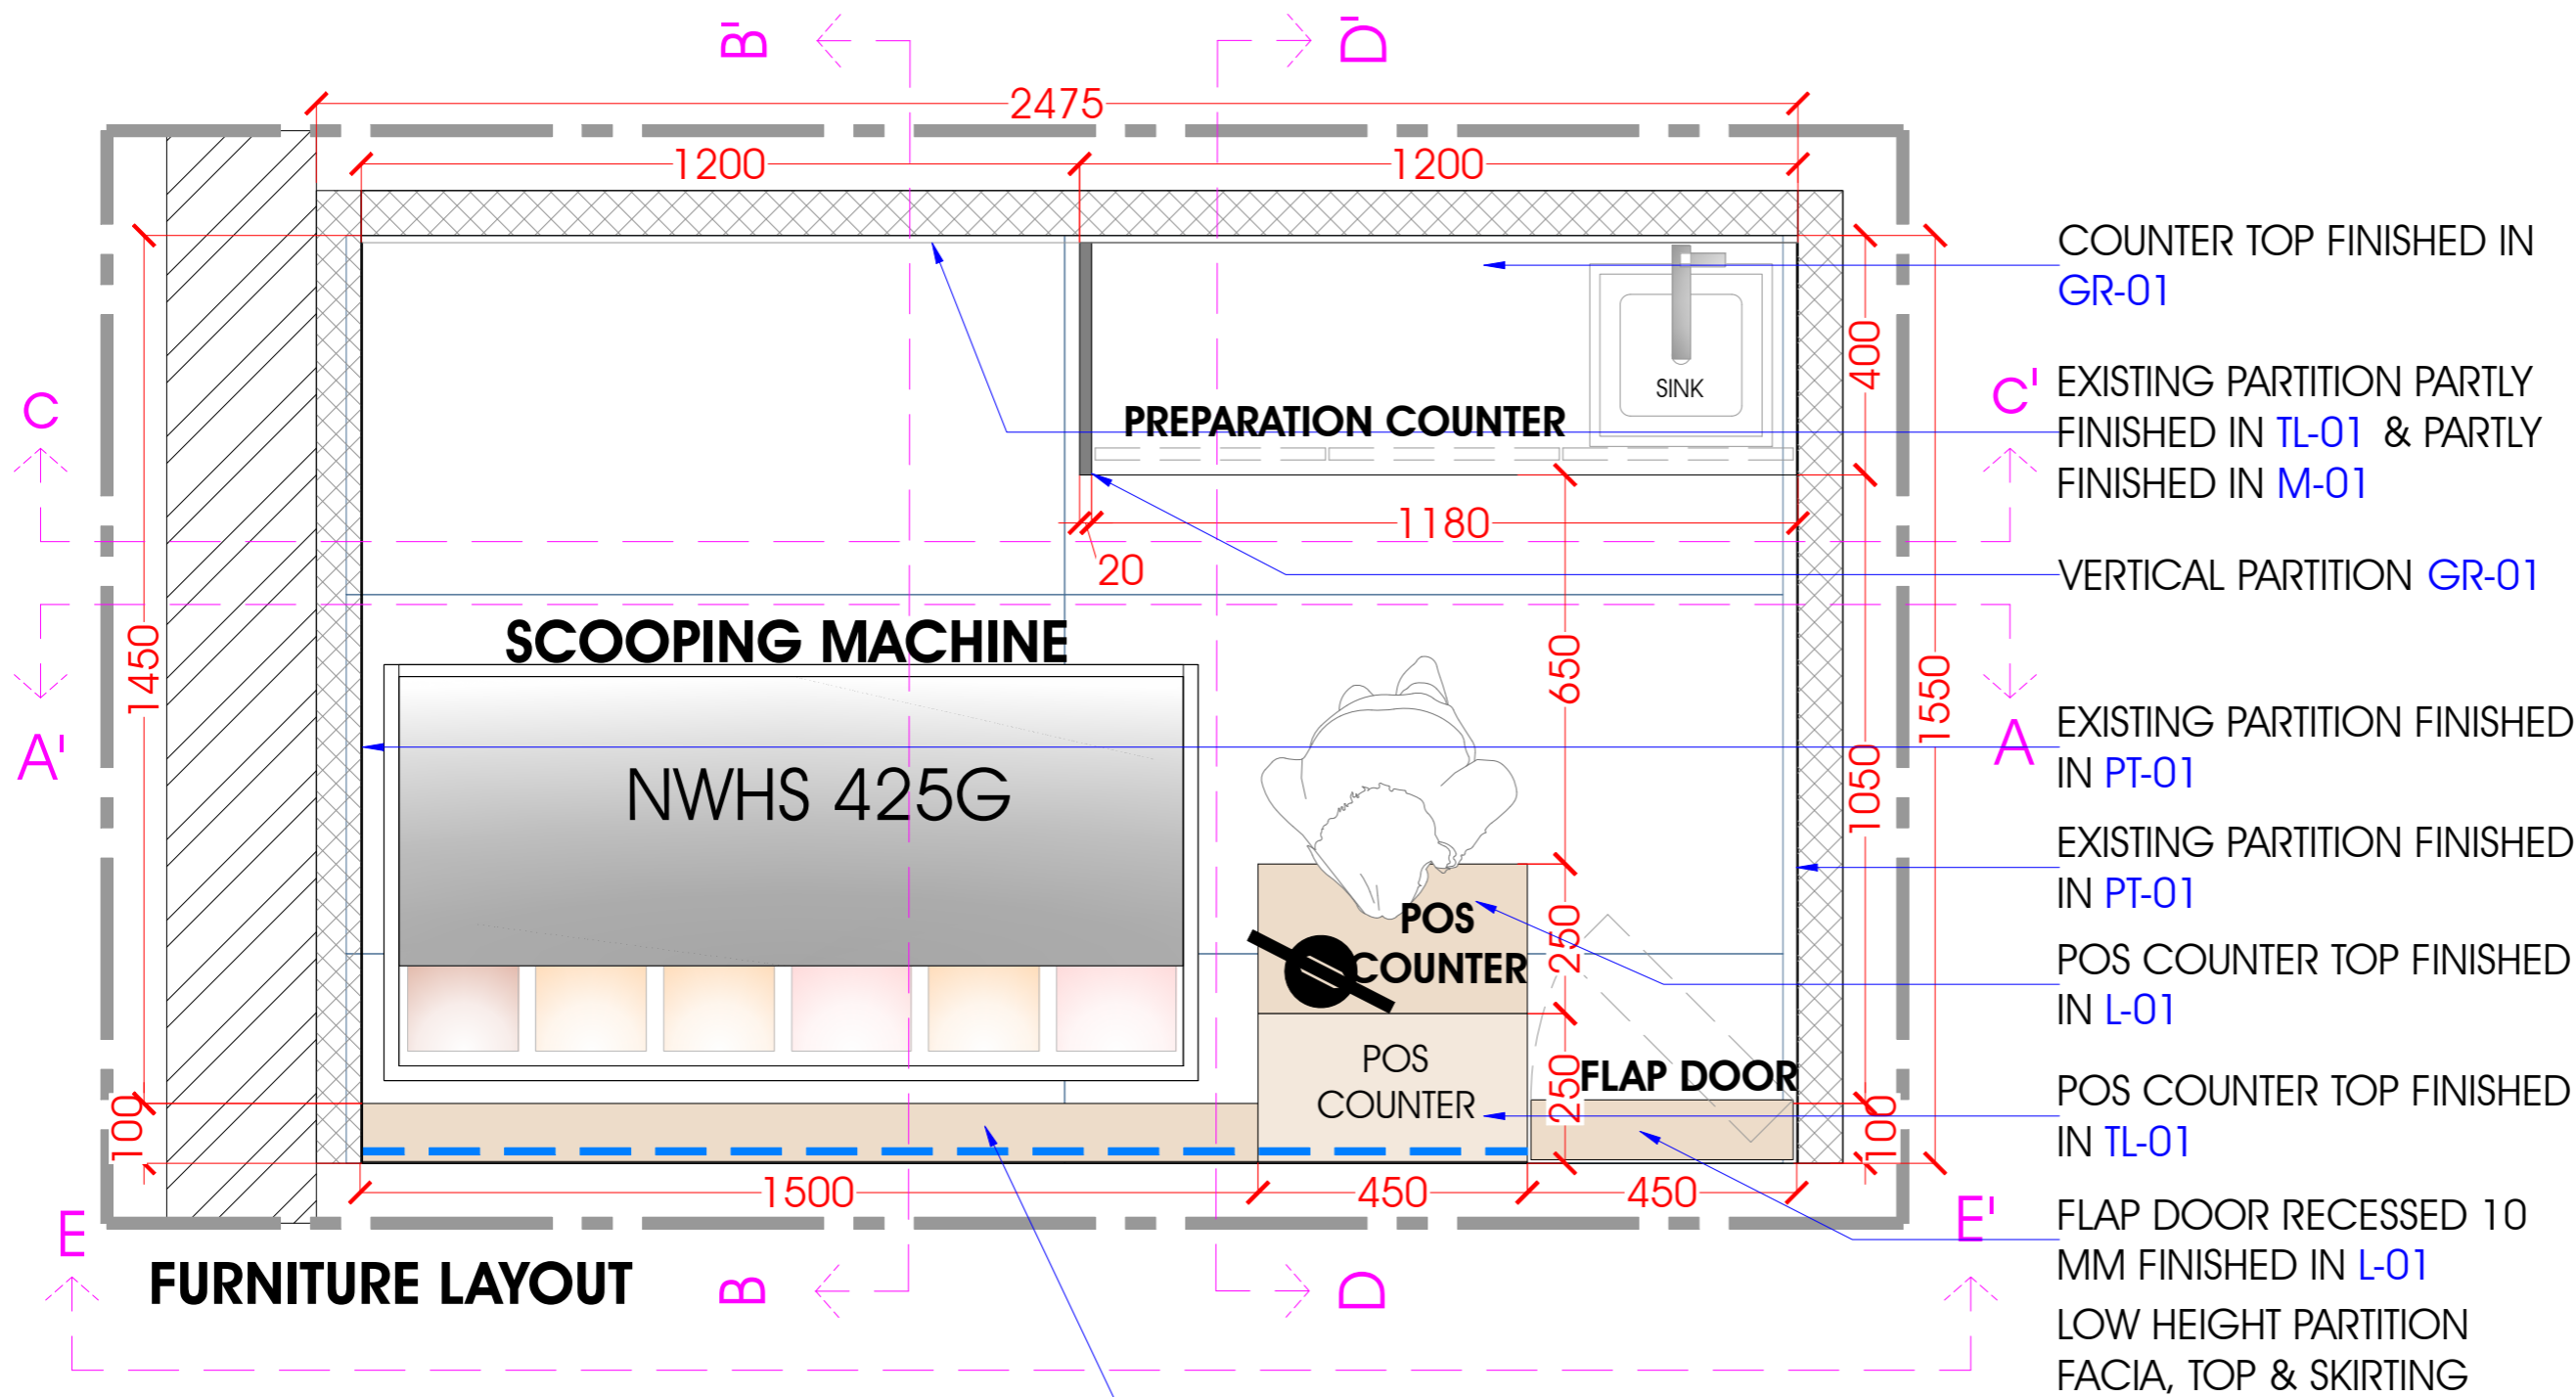AREA : AREA - 42 SQFT
NORTH :




FINISH LEGEND


IMAGE	INDICATION	DESCRIPTION	IMAGE	INDICATION	DESCRIPTION
	TL-01	COMPANY -NEXION SERIES -ENDLESS BIANCO SIZE - 1200MM X600MM		L-01	COMPANY - GREENLAM LAMINATES SERIES - 2020_2022 COLLECTION CODE - 133 SUD MOON STONE
	PT-01	COMPANY - ASIAN PAINT CODE - 0684 Crusade-N AP Y 0914-0714M		GR-01	BLACK GRANITE
	M-01	5/6MM GREY TINTED MIRROR (EDGE TO BE MACHINE POLISHED)			

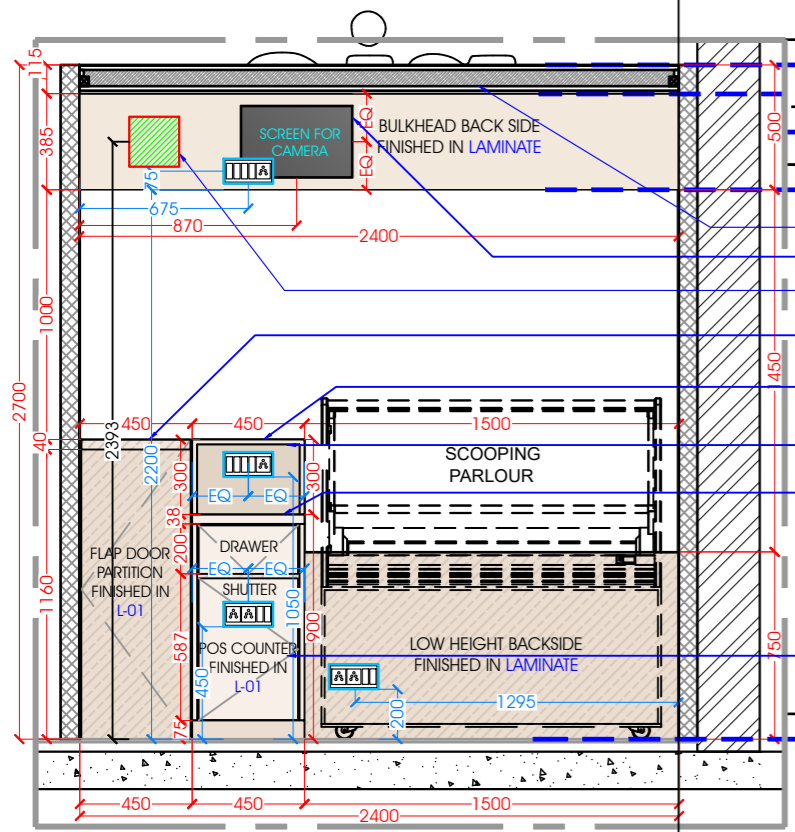


SECTIONAL ELEVATION AA'

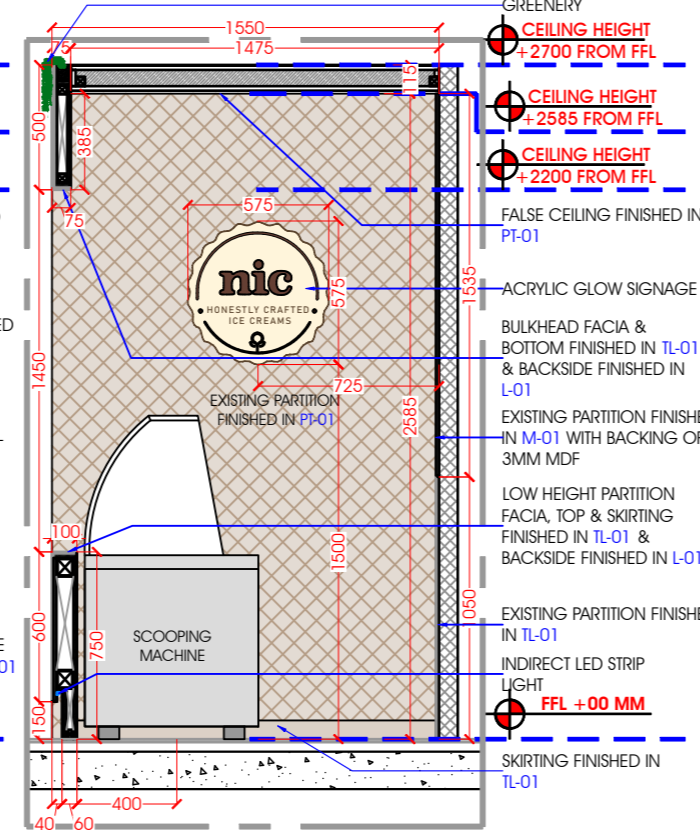


SECTIONAL ELEVATION BB'

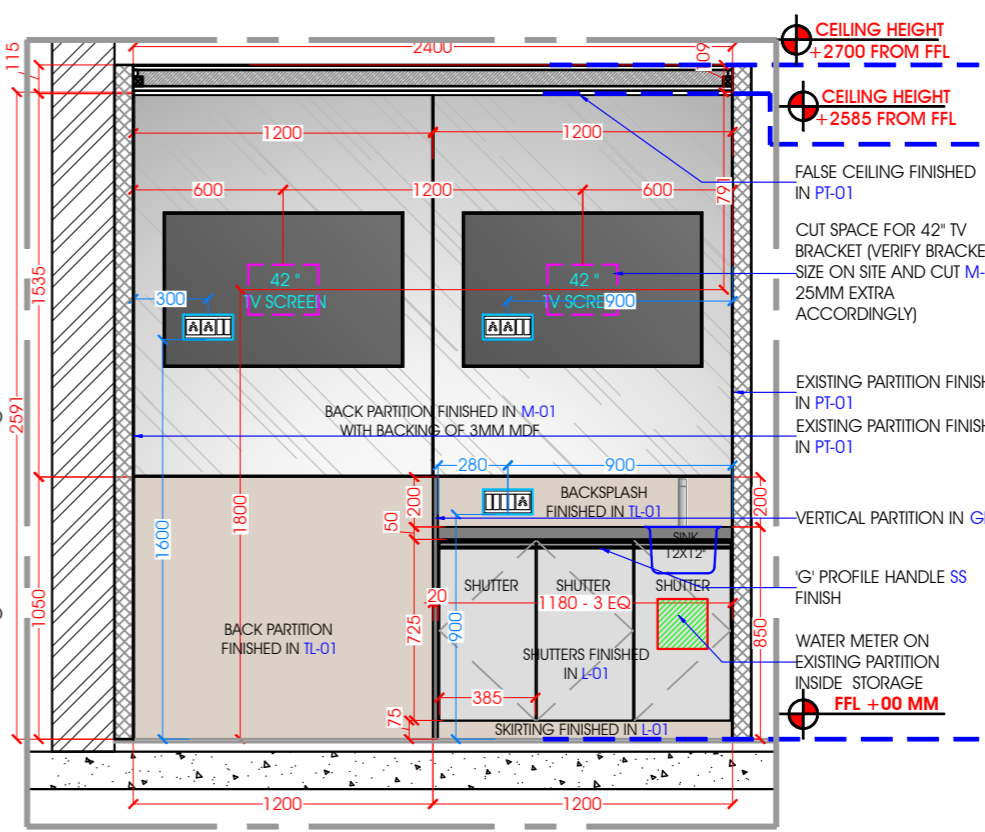

SECTIONAL ELEVATION CC'

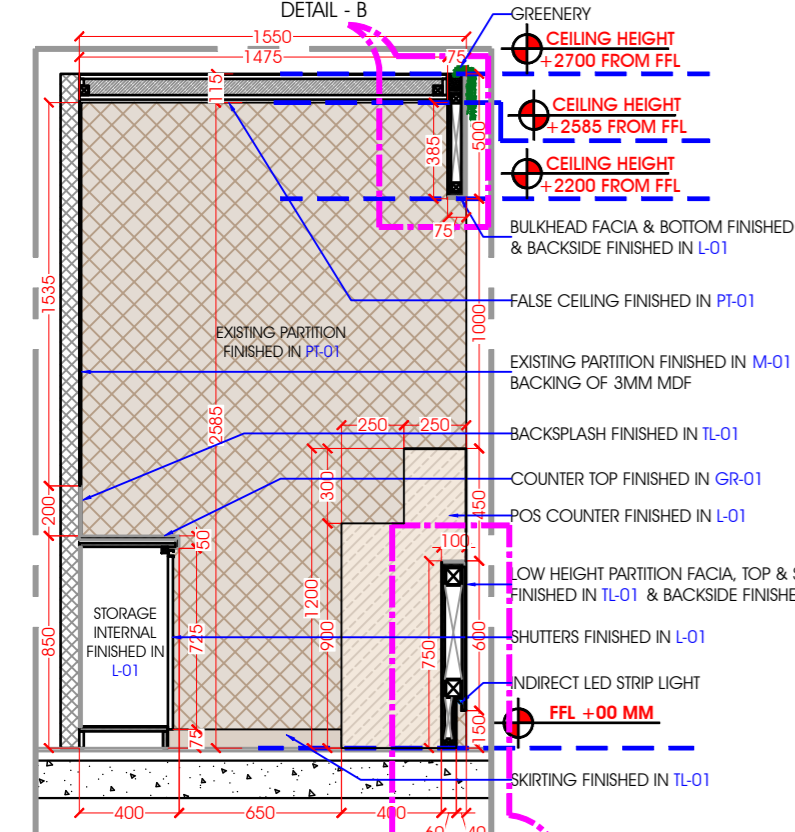


SECTIONAL ELEVATION DD'

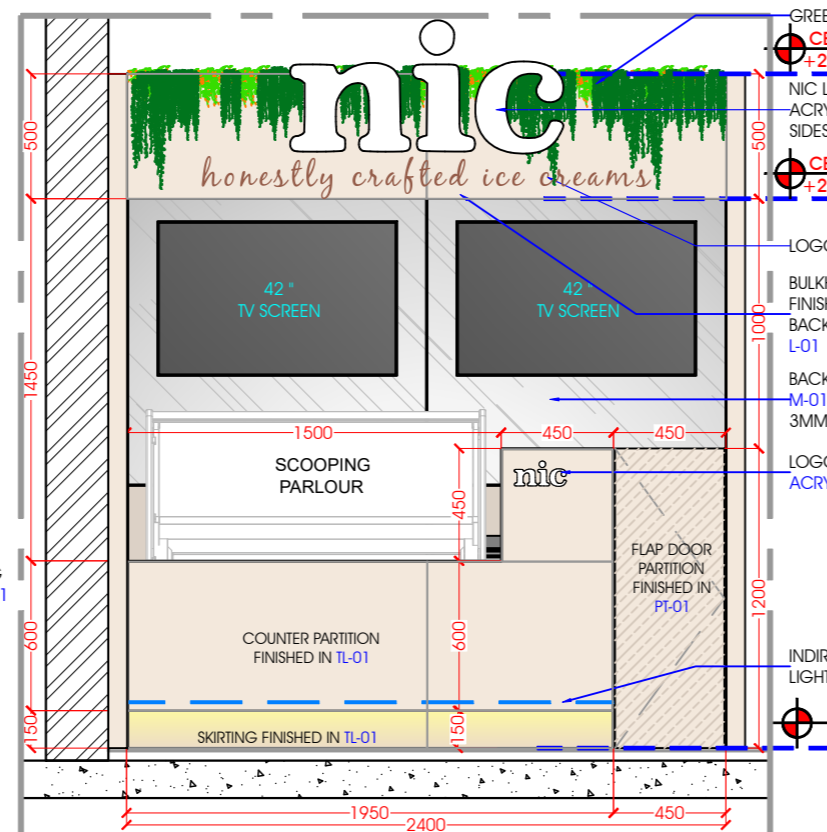

SECTIONAL ELEVATION EE'



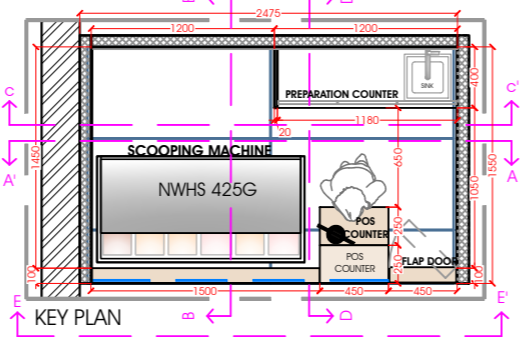3D VIEW



KEY PLAN

FINISH LEGEND					
IMAGE	INDICATION	DESCRIPTION	IMAGE	INDICATION	DESCRIPTION
	TL-01	COMPANY - NEXION SERIES - ENDLESS BIANCO SIZE - 1200MM X 600MM		L-01	COMPANY - GREENLAM LAMINATES SERIES - 2020_2022 COLLECTION CODE - 133 SUD MOON STONE
	PT-01	COMPANY - ASIAN PAINT CODE - 0684 Crusade-N AP Y 0914-0714M		GR-01	BLACK GRANITE
	M-01	5/6MM GREY TINTED MIRROR (EDGE TO BE MACHINE POLISHED)			

DESIGNERS : _____ Authorized Signature : _____

DRAWING SUPERVISORS : _____

PROJECT NUMBER : S-00

PROJECT NAME : _____

NIC ICE CREAM - LUCKNOW AIRPORT TERMINAL 3

DRAWING TITLE : _____

SECTIONAL ELEVATIONS

ISSUED / REVISION :

NO.	DATE	REMARKS
1.		
2.		
3.		
4.		
5.		

DRAWN BY : JAY P. DRAWING NO. S-03

CHECKED BY : AMITA C.

SCALE : N T S DATE : 03-04-2024

AREA : AREA - 42 SQFT NORTH :

DESIGNERS : Authorized Signature :

DRAWING SUPERVISORS :

PROJECT NUMBER : S-00

PROJECT NAME :

NIC ICE CREAM -
LUCKNOW AIRPORT
TERMINAL 3

DRAWING TITLE :

WALL FINISH LAYOUT

ISSUED / REVISION :


NO.	DATE	REMARKS
1.		
2.		
3.		
4.		
5.		

DRAWN BY : JAY P. DRAWING NO. S - 04

CHECKED BY : AMITA C.

SCALE : N T S DATE : 03-04-2024

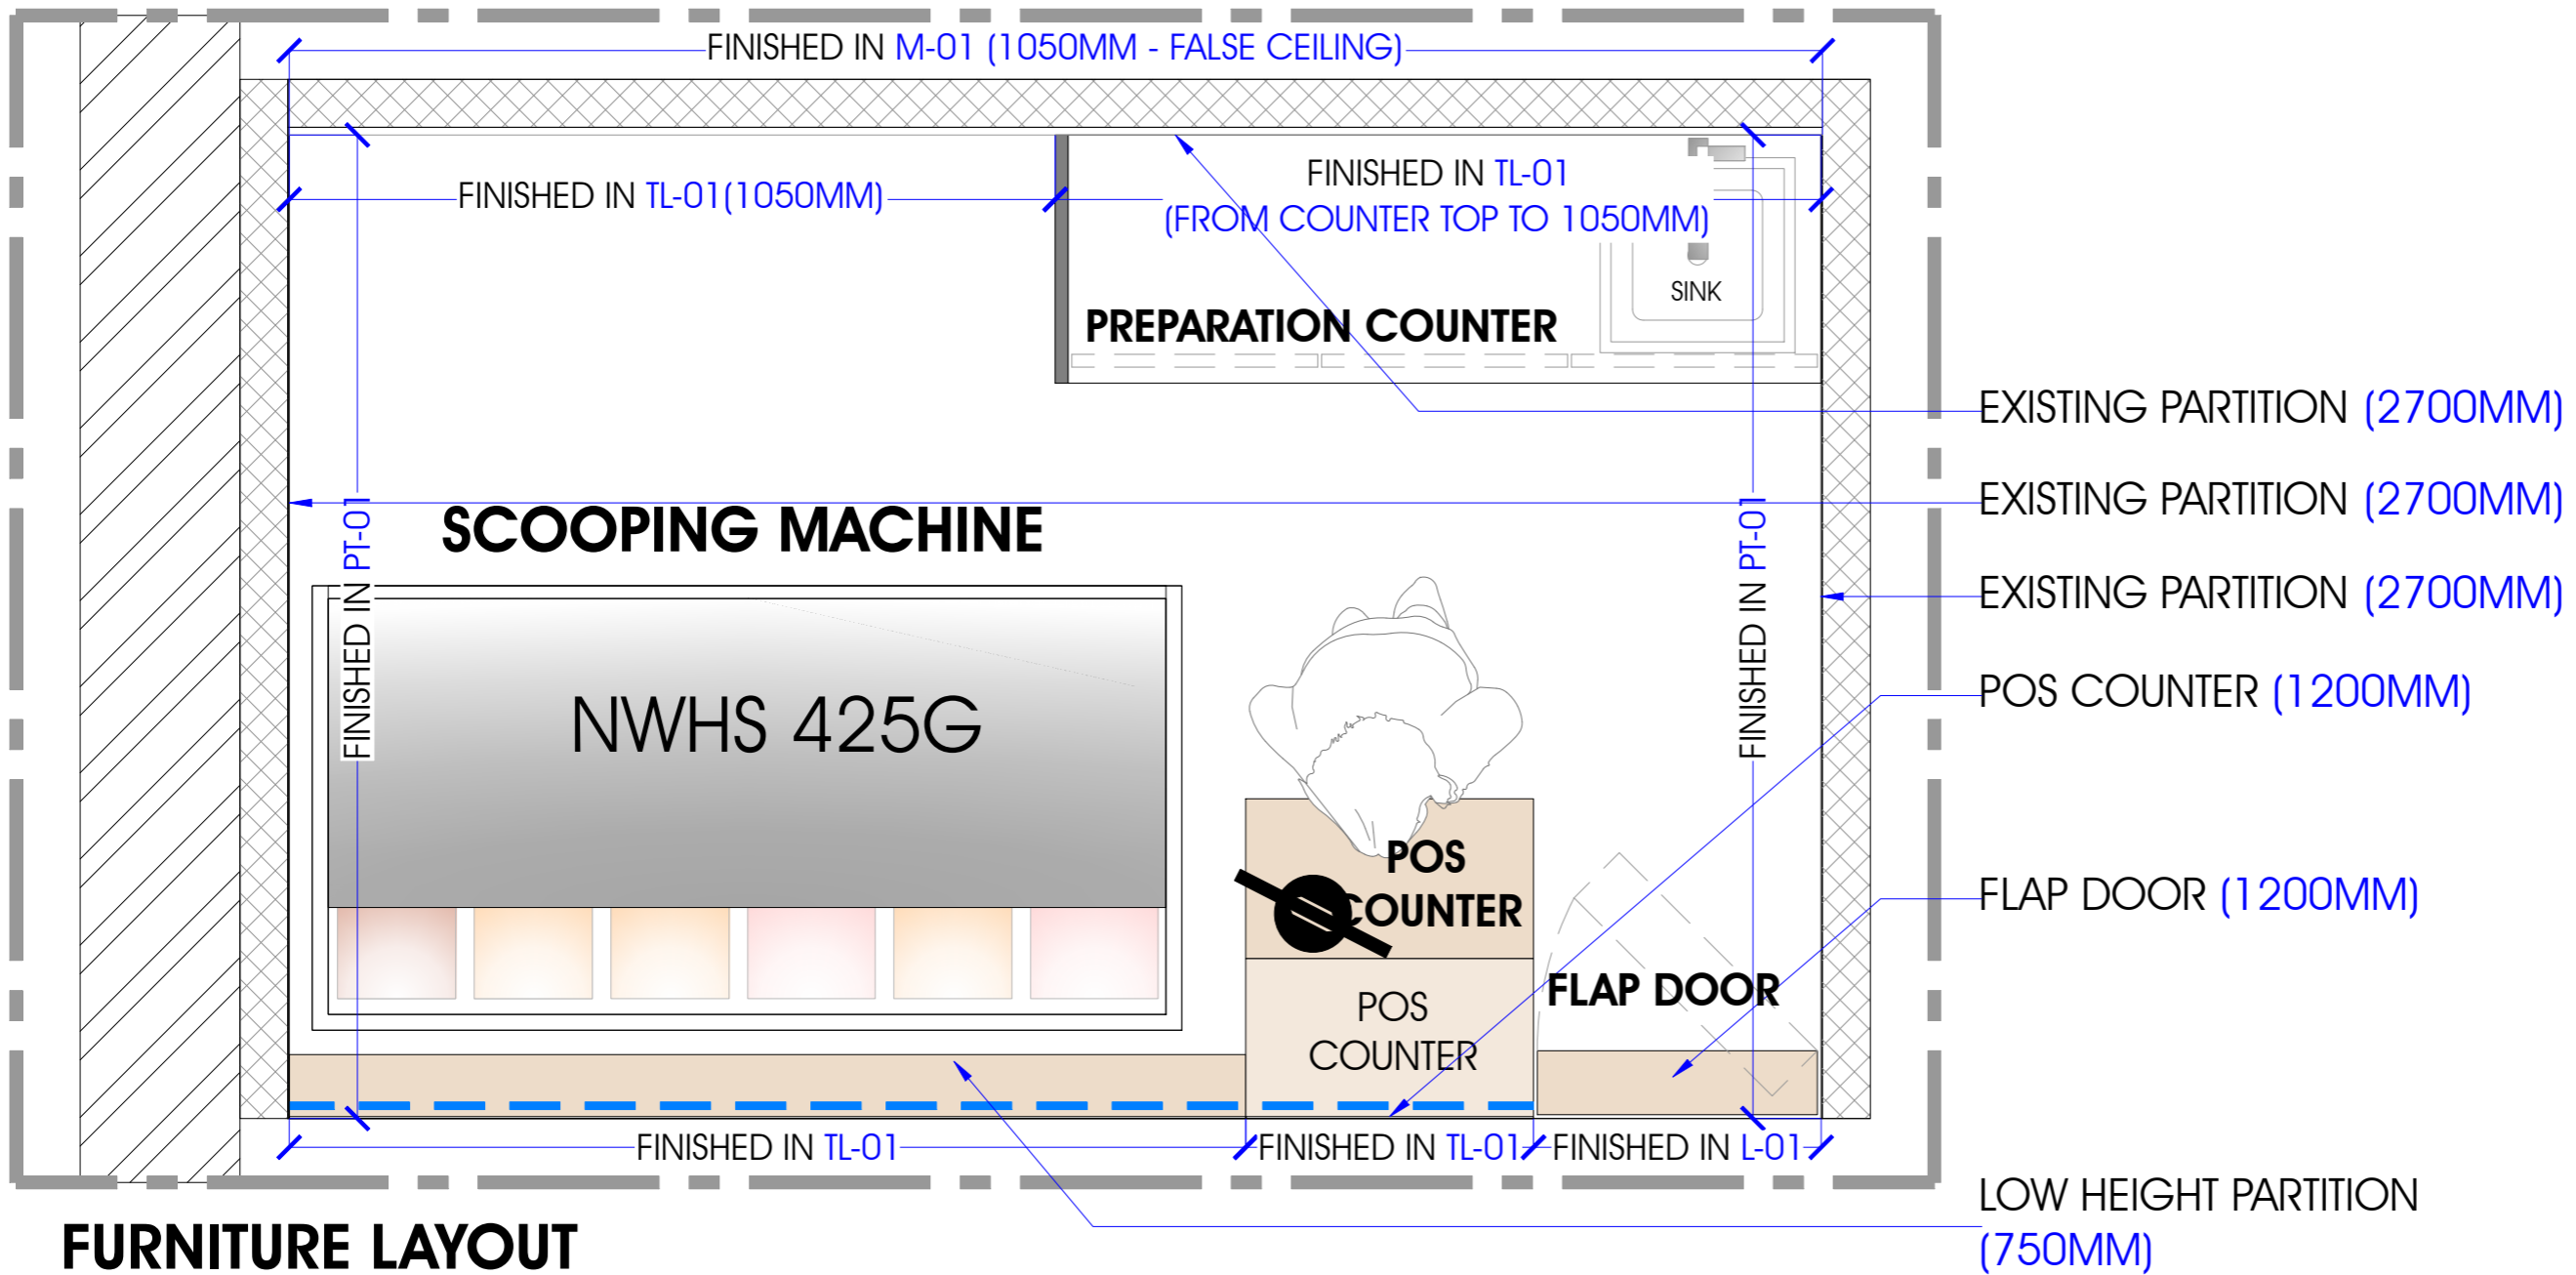AREA : AREA - 42 SQFT NORTH :



FURNITURE LAYOUT

FINISH LEGEND

IMAGE	INDICATION	DESCRIPTION	IMAGE	INDICATION	DESCRIPTION
	TL-01	COMPANY -NEXION SERIES -ENDLESS BIANCO SIZE - 1200MM X600MM		L-01	COMPANY - GREENLAM LAMINATES SERIES - 2020_2022 COLLECTION CODE - 133 SUD MOON STONE
	PT-01	COMPANY - ASIAN PAINT CODE - 0684 Crusade-N AP Y 0914-0714M		GR-01	BLACK GRANITE
	M-01	5/6MM GREY TINTED MIRROR (EDGE TO BE MACHINE POLISHED)			

DESIGNERS : _____ Authorized Signature : _____

DRAWING SUPERVISORS : _____

PROJECT NUMBER : _____ S-00

PROJECT NAME :

NIC ICE CREAM -
 LUCKNOW AIRPORT
 TERMINAL 3

DRAWING TITLE :

FLOORING LAYOUT

ISSUED / REVISION :

NO.	DATE	REMARKS
1.		
2.		
3.		
4.		
5.		

DRAWN BY : JAY P.

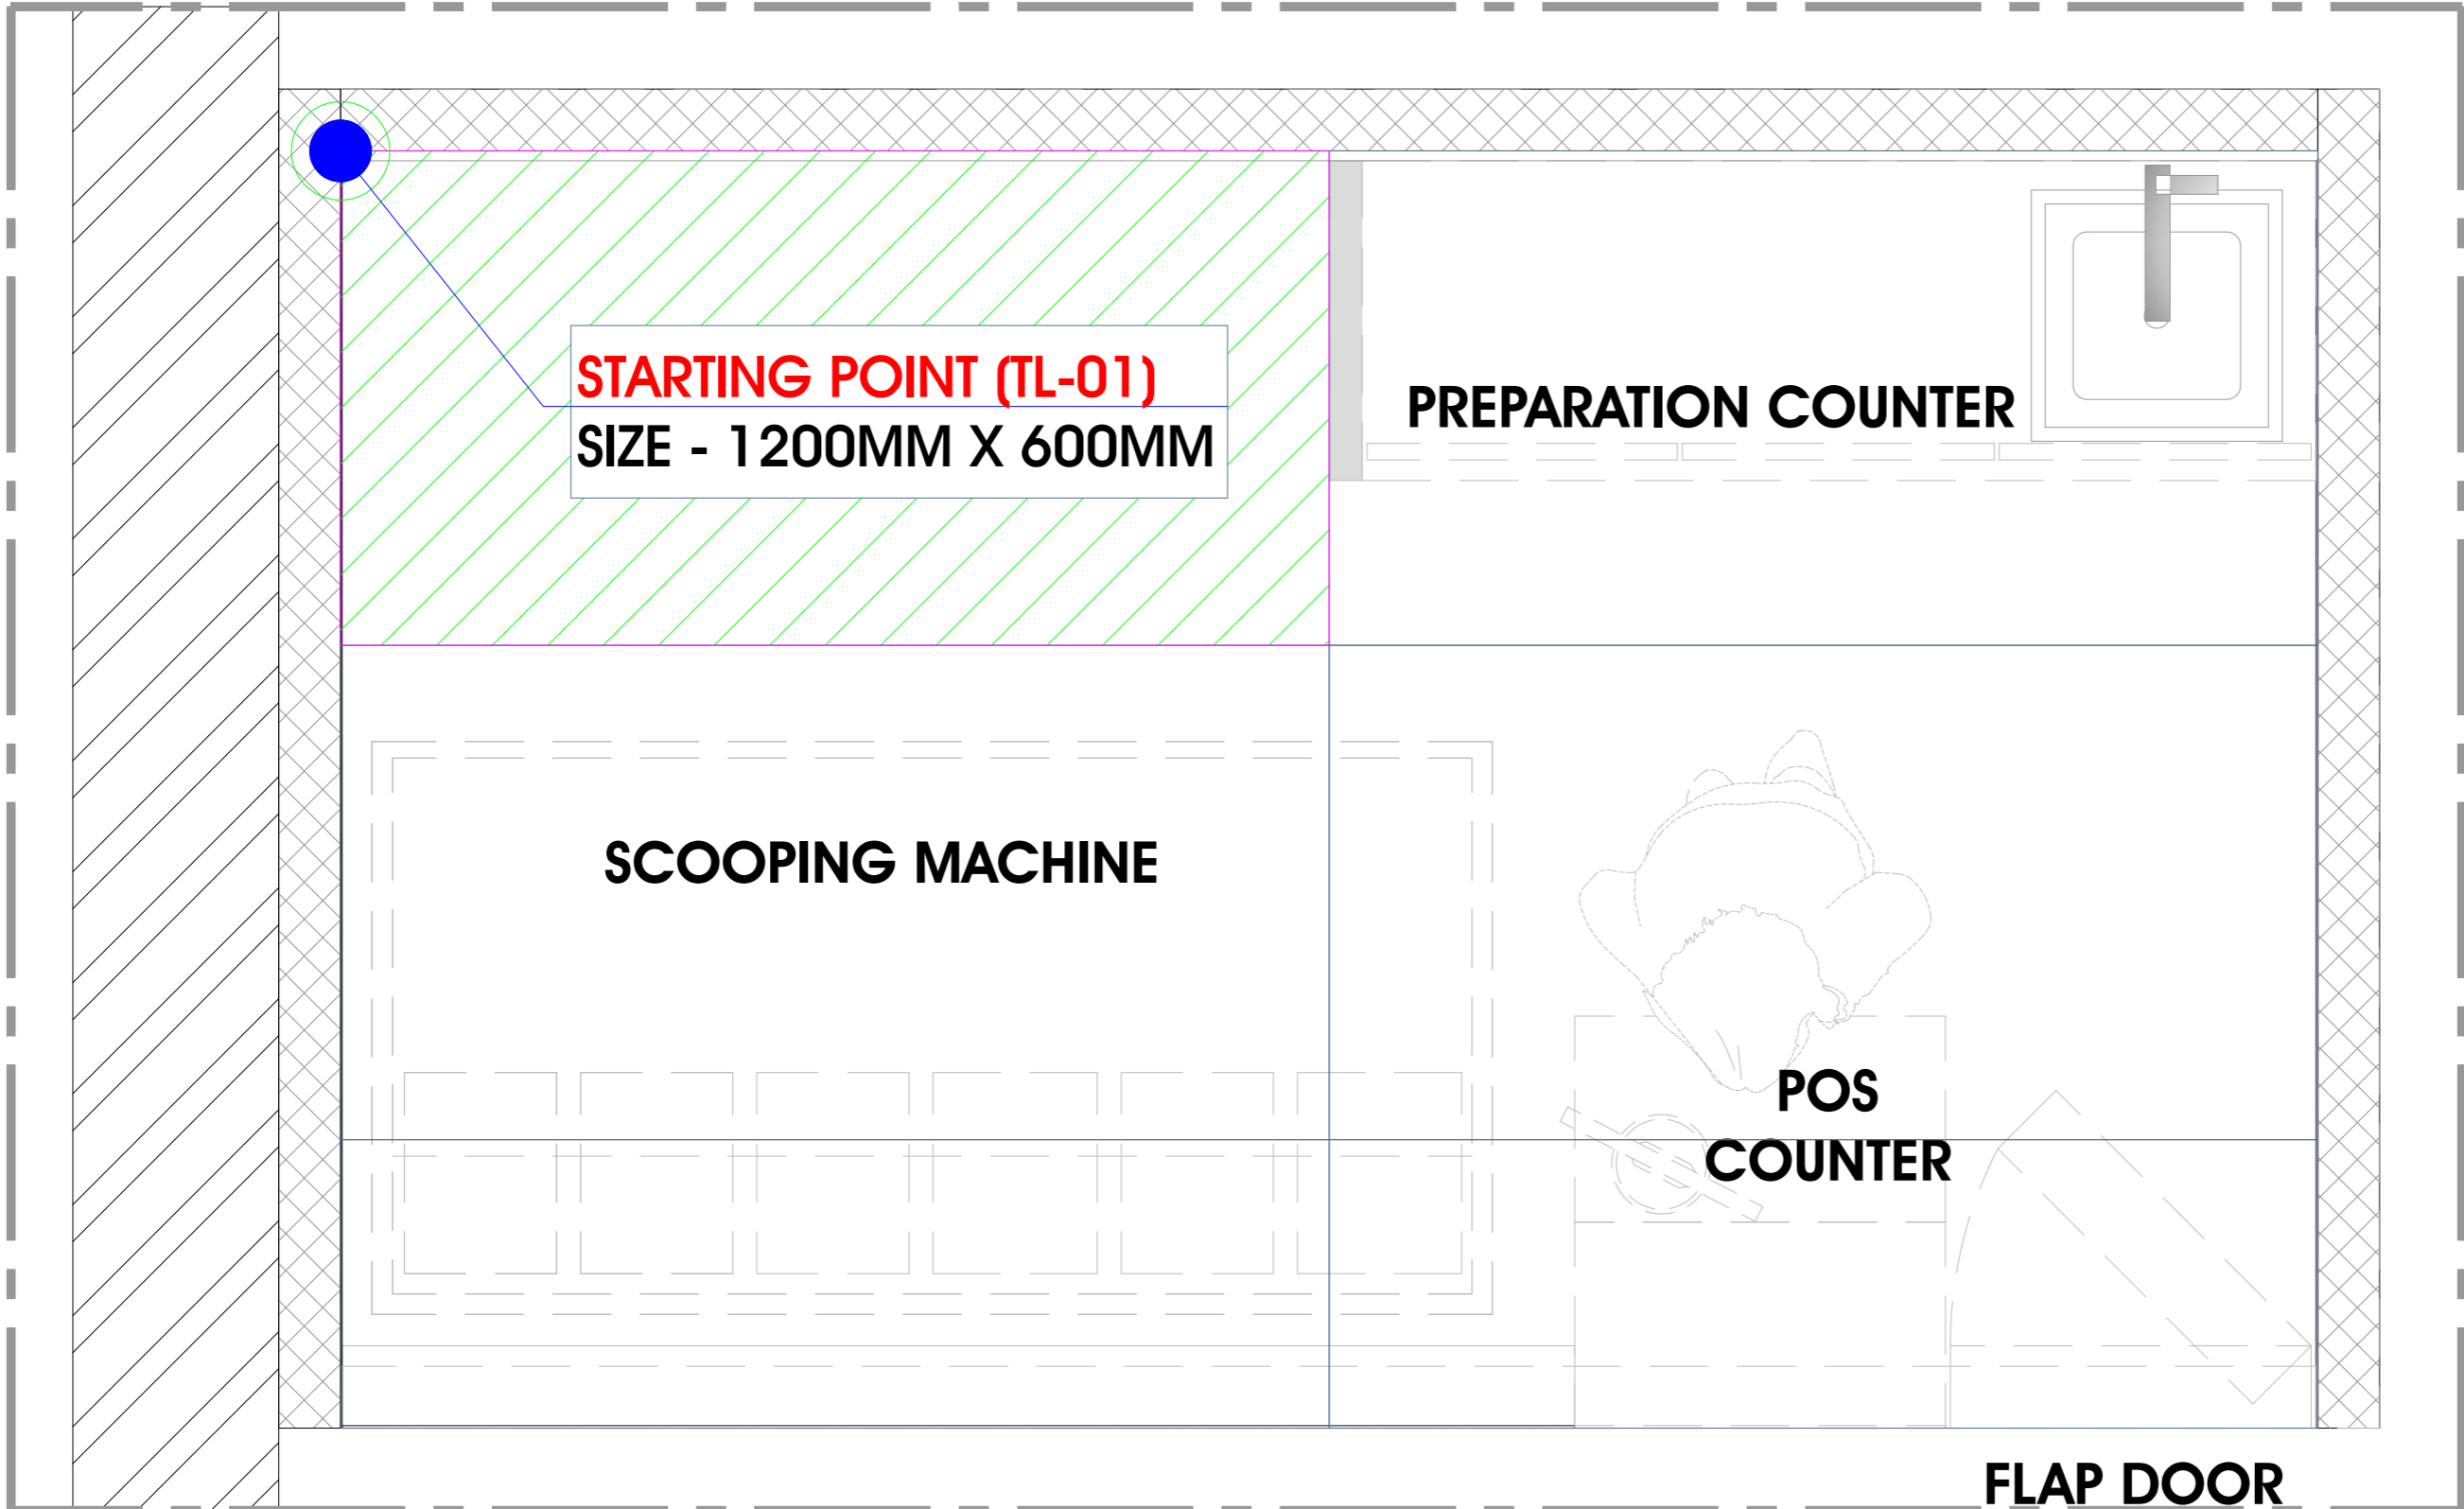
DRAWING NO.

S - 05

CHECKED BY : AMITA C.

SCALE : N T S DATE : 03-04-2024

AREA : AREA - 42 SQFT NORTH :



FINISH LEGEND

IMAGE	INDICATION	DESCRIPTION
	TL-01	COMPANY -NEXION SERIES -ENDLESS BIANCO SIZE - 1200MM X600MM

DESIGNERS : _____ Authorized Signature : _____

DRAWING SUPERVISORS : _____

PROJECT NUMBER : _____ S-00

PROJECT NAME :

NIC ICE CREAM -
LUCKNOW AIRPORT
TERMINAL 3

DRAWING TITLE :

SWITCHBOARD LAYOUT


ISSUED / REVISION :

NO.	DATE	REMARKS
1.		
2.		
3.		
4.		
5.		

DRAWN BY : JAY P.
DRAWING NO. S - 06
CHECKED BY : AMITA C.

SCALE : N T S
DATE : 03-04-2024

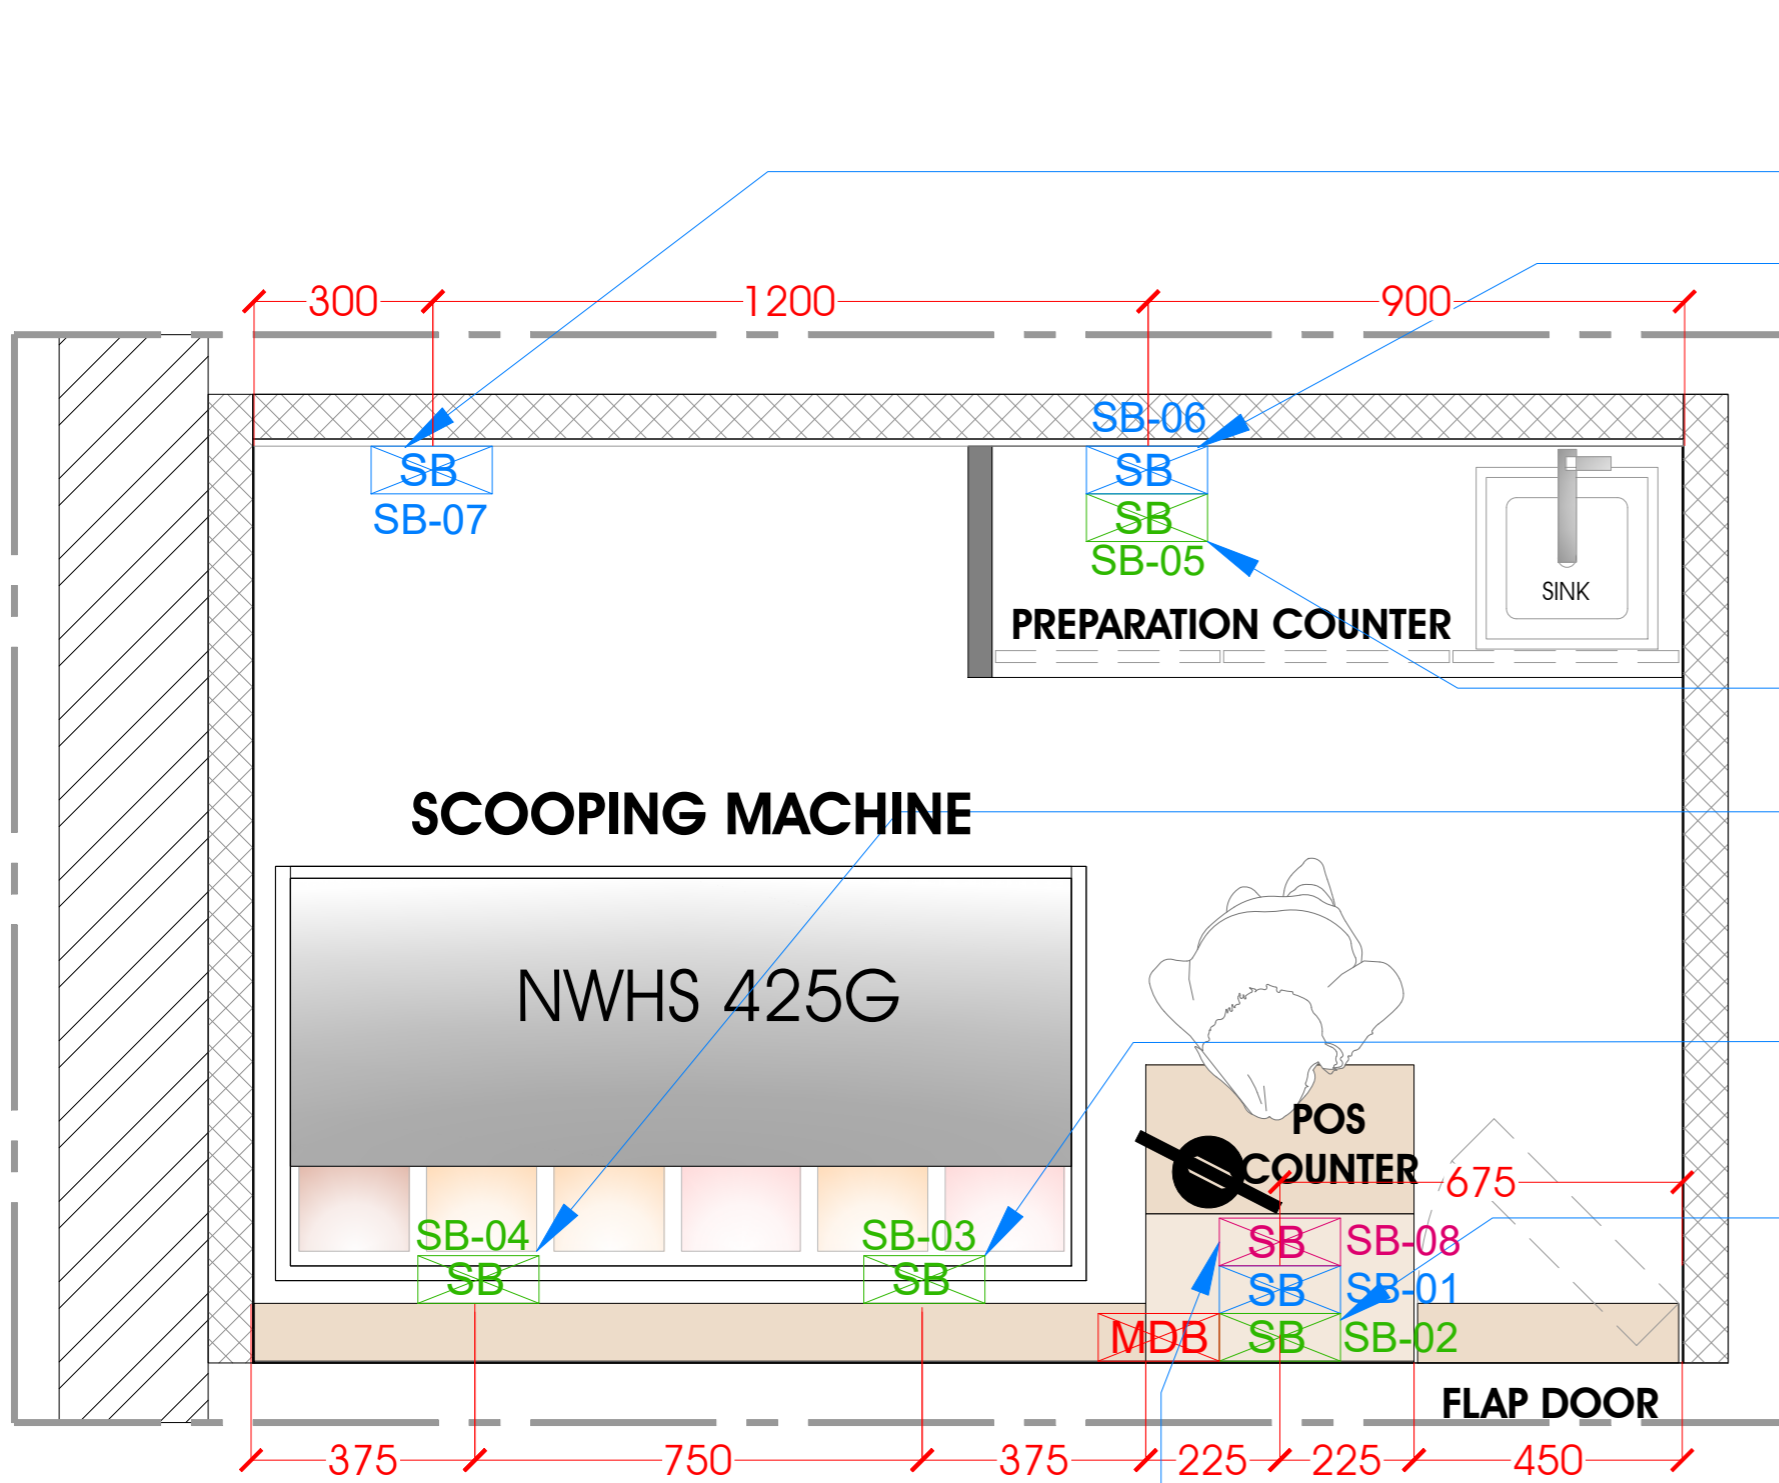AREA : AREA - 42 SQFT
NORTH :



SB-07 BOB @ 1800 MM
-5AMP -1 NOS SWITCH AND SOCKET
FOR TV PLUG

SB-06 BOB @ 1800 MM
-5AMP -1 NOS SWITCH AND SOCKET
FOR TV PLUG

SB-05 BOB @ HT 900 MM
-5AMP-1NOS SWITCH AND SOCKET,
15AMP-1NOS SWITCH AND SOCKET
FOR UTILITY PURPOSE &

SB- 04 BOB @ HT 200 MM
- 15AMP- 2NOS OF SWITCH AND SOCKET FOR FREEZERS

SB- 03 BOB @ HT 200 MM
- 15AMP- 2NOS OF SWITCH AND SOCKET FOR FREEZERS

SB01- BOB @ HT 1050 MM
- 5AMP-2 NOS OF SWITCH AND SOCKET
-LIGHT CONTROL SWITCHES
-TV SCREEN SWITCH
-5AMP-1NOS SWITCH FOR INDIRECT LED LIGHTS
-5AMP-1NOS SWITCH FOR SPEAKERS

SB- 02 BOB @ 450 MM
- 5AMP-2NOS OF SWITCH AND SOCKET
-INTERNET, LAN & HDMI PT
-CAMERA
-DVR
-MCB FOR ALL LIGHTS

SB-08 BOB @ 2225 MM
-5AMP -1 NOS SWITCH AND SOCKET
FOR DVR SCREEN PLUG

LEGEND

NOS	SYMBOL	DESCRIPTION
1		SWITCHBOARD LOCATION
2		MCB FOR ALL LIGHTS

DESIGNERS : Authorized Signature :

DRAWING SUPERVISORS :

PROJECT NUMBER : S-00

PROJECT NAME :

NIC ICE CREAM -
 LUCKNOW AIRPORT
 TERMINAL 3

DRAWING TITLE :

PLUMBING LAYOUT

ISSUED / REVISION :


NO.	DATE	REMARKS
1.		
2.		
3.		
4.		
5.		

DRAWN BY : JAY P. DRAWING NO. S - 07

CHECKED BY : AMITA C.

SCALE : N T S DATE : 03-04-2024

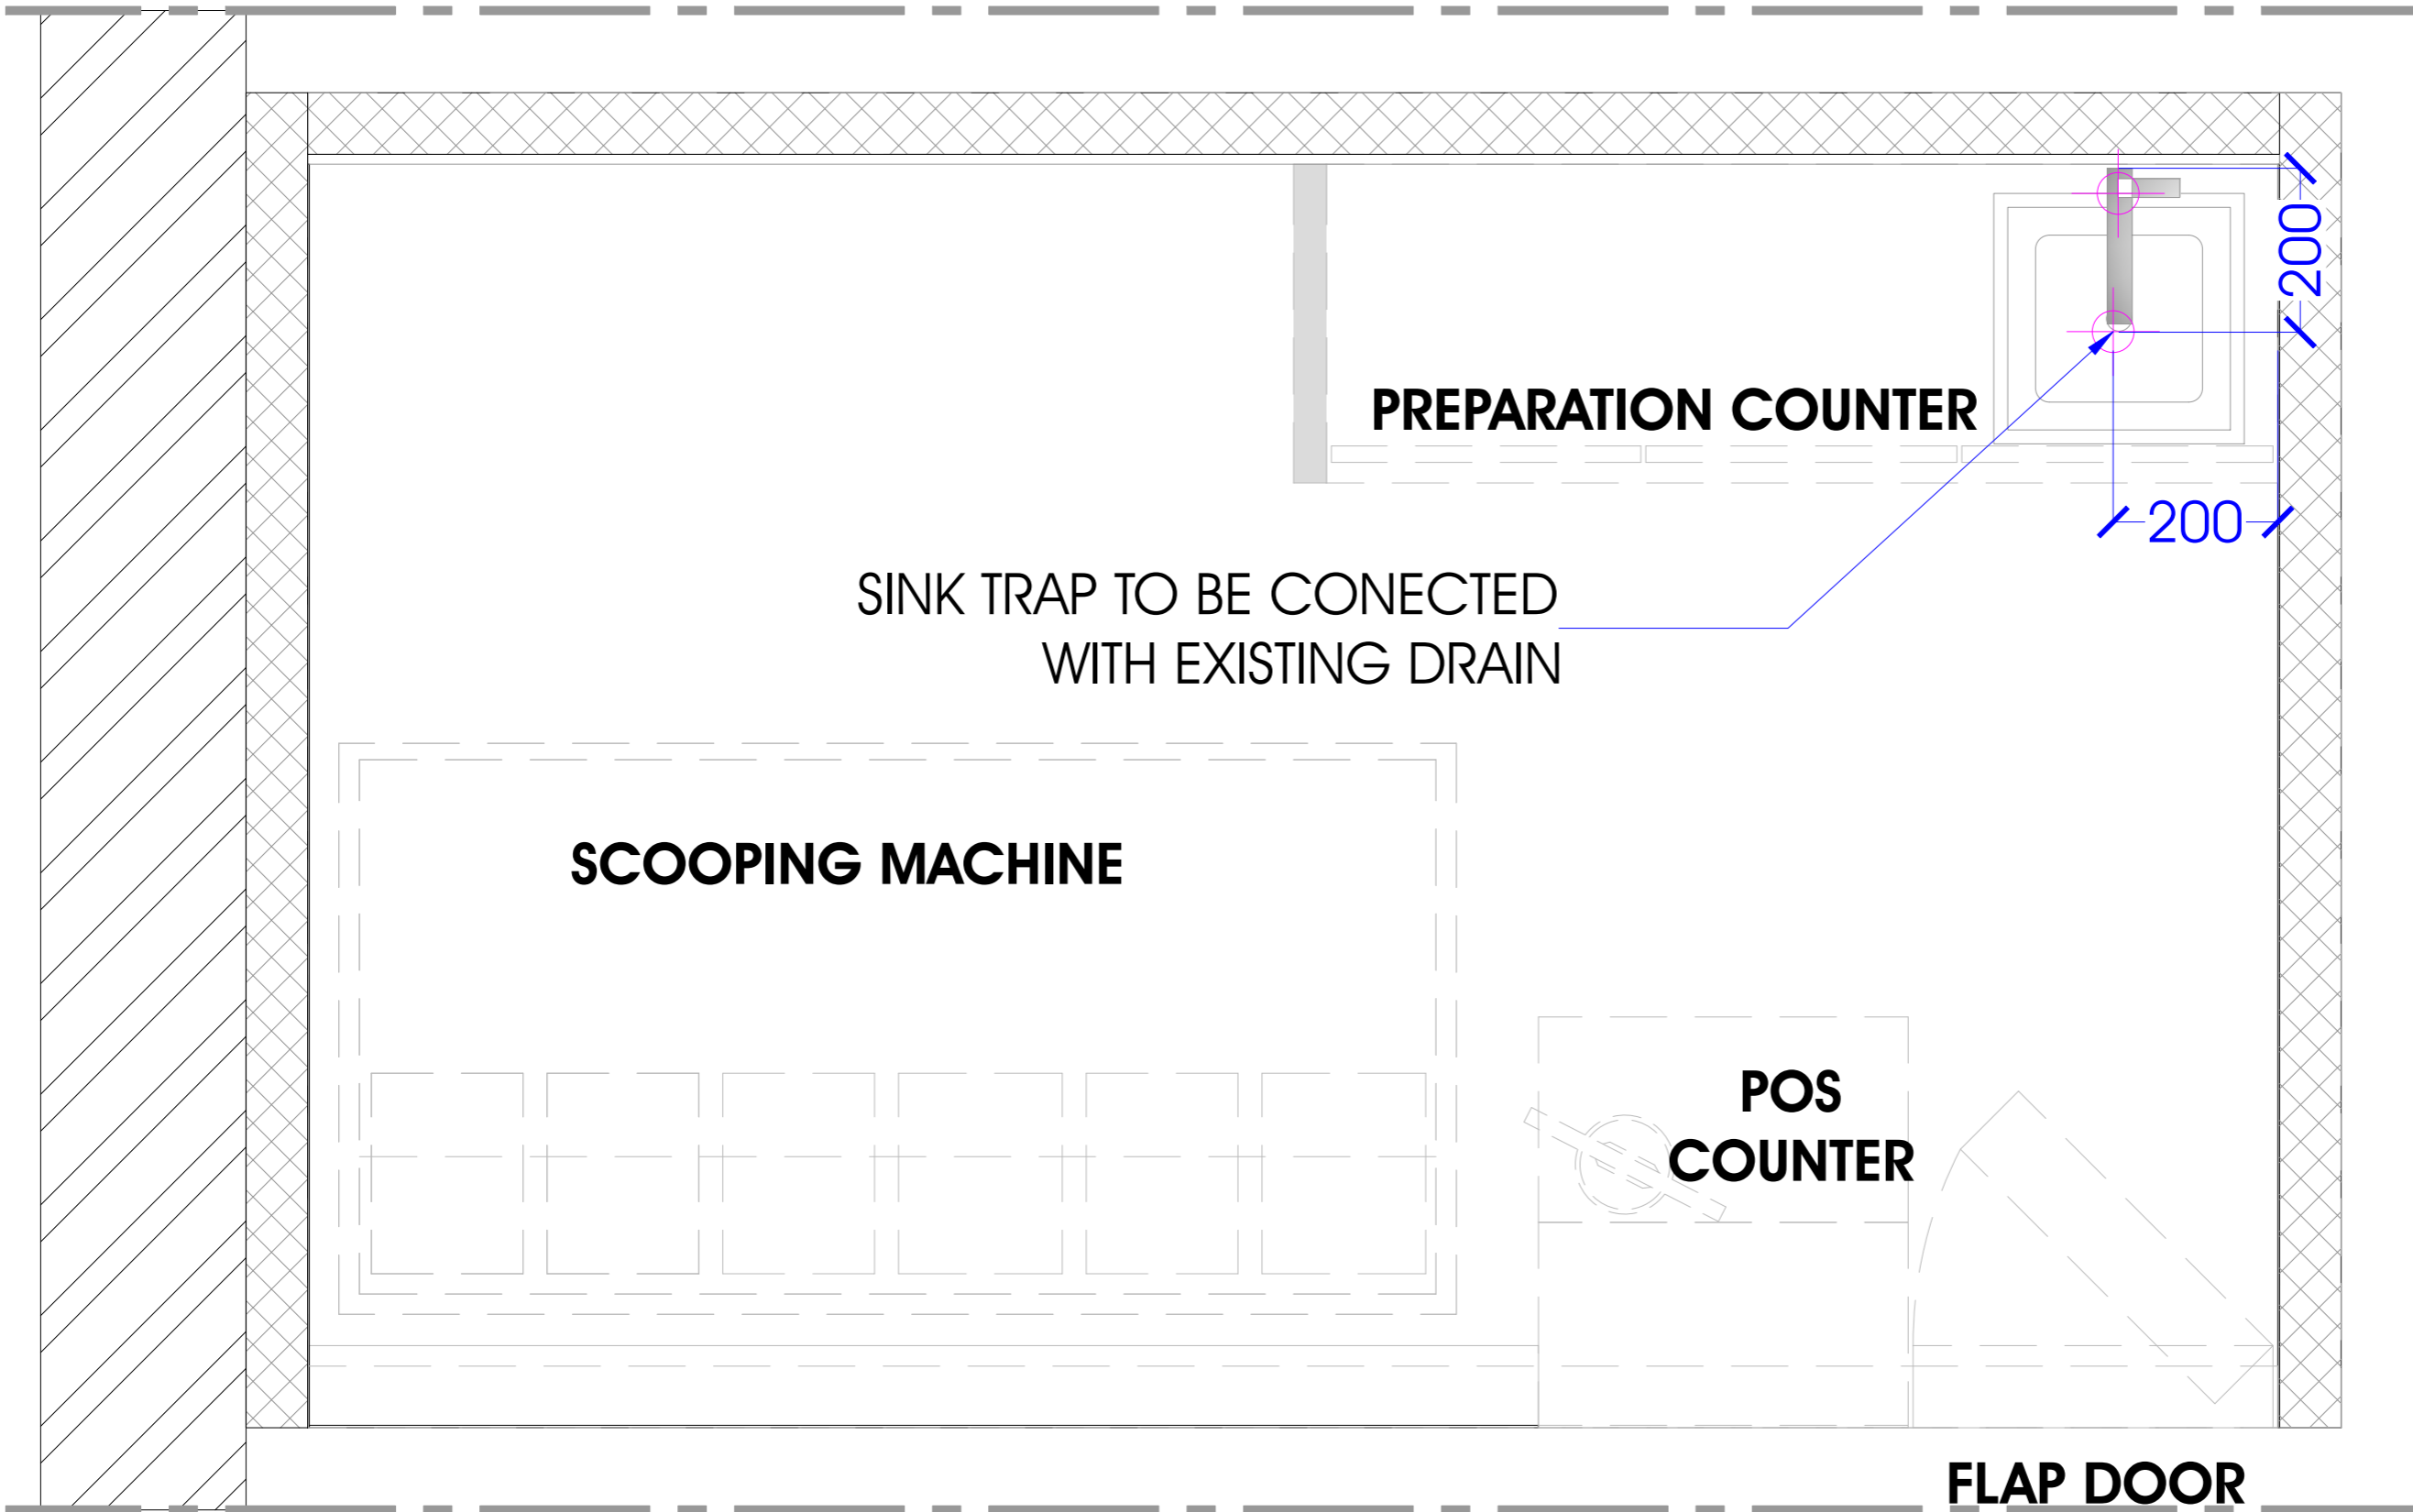AREA : AREA - 42 SQFT NORTH :



LEGEND	
SYMBOL	DESCRIPTION
	PLUMBING POINT

DESIGNERS : _____
Authorized Signature : _____

DRAWING SUPERVISORS : _____

PROJECT NUMBER : S-00

PROJECT NAME :

NIC ICE CREAM -
LUCKNOW AIRPORT
TERMINAL 3

DRAWING TITLE :

FALSE CEILING LAYOUT

ISSUED / REVISION :


NO.	DATE	REMARKS
1.		
2.		
3.		
4.		
5.		

DRAWN BY : JAY P.
DRAWING NO. S - 08

CHECKED BY : AMITA C.


SCALE : N T S
DATE : 03-04-2024

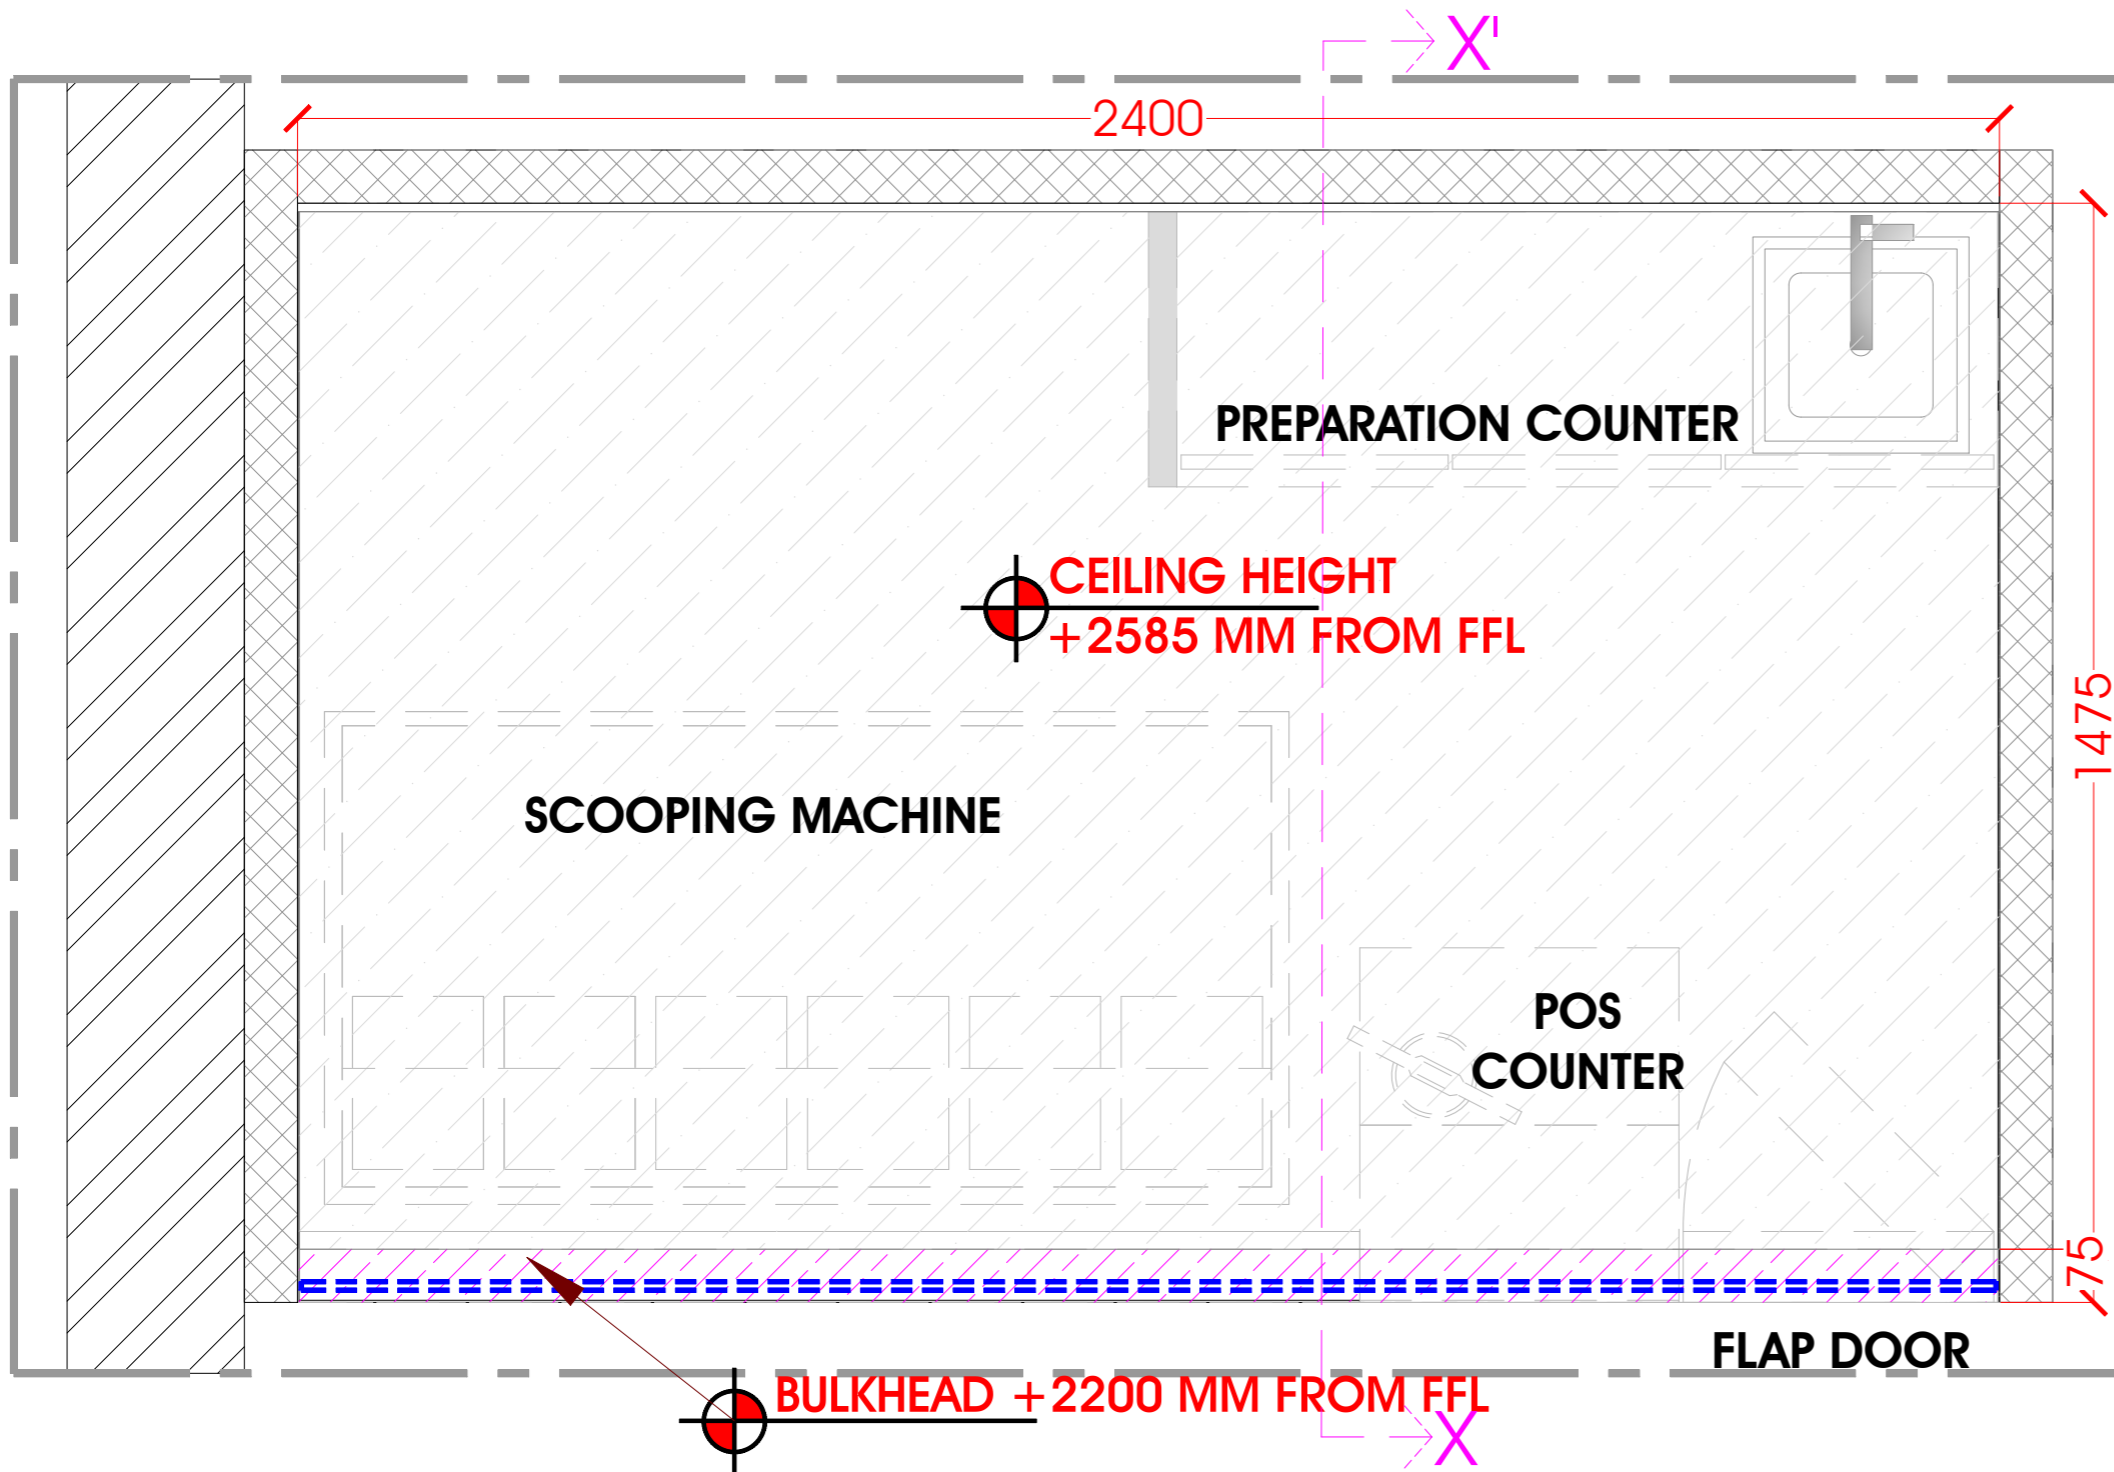AREA : AREA - 42 SQFT
NORTH :



FINISH LEGEND		
IMAGE	INDICATION	DESCRIPTION
	TL-01	COMPANY -NEXION SERIES -ENDLESS BIANCO SIZE - 1200MM X600MM
	PT-01	COMPANY - ASIAN PAINT CODE - 0684 Crusade-N AP Y 0914-0714M

FALSE CEILING LEGEND		
INDICATION	DESCRIPTION	MATERIAL
	+ 2585 MM FROM FFL	GYPSUM FINISHED IN PT-01
	BULKHEAD + 2200 MM FROM FFL	TL-01

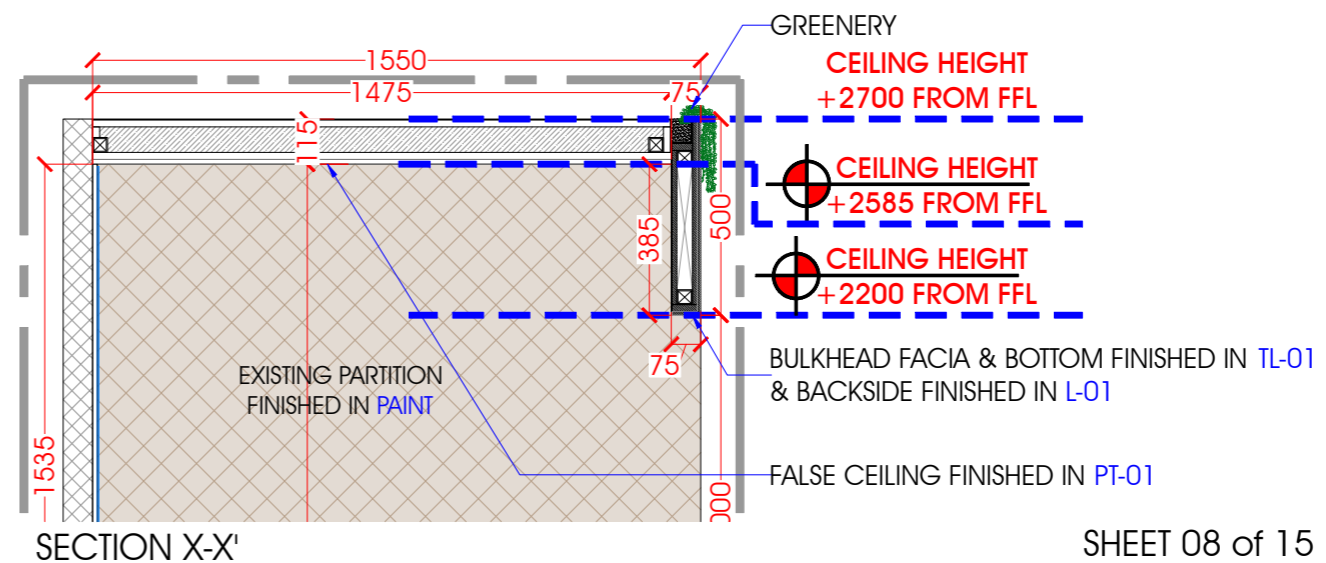

SHEET 08 of 15

DESIGNERS : _____ Authorized Signature : _____

DRAWING SUPERVISORS : _____

PROJECT NUMBER : S-00

PROJECT NAME :

NIC ICE CREAM -
LUCKNOW AIRPORT
TERMINAL 3

DRAWING TITLE :

ELECTRICAL LAYOUT

ISSUED / REVISION :


NOS.	DATE	REMARKS
1.		
2.		
3.		
4.		
5.		

DRAWN BY : JAY P. DRAWING NO. S-09

CHECKED BY : AMITA C.

SCALE : N T S DATE : 03-04-2024

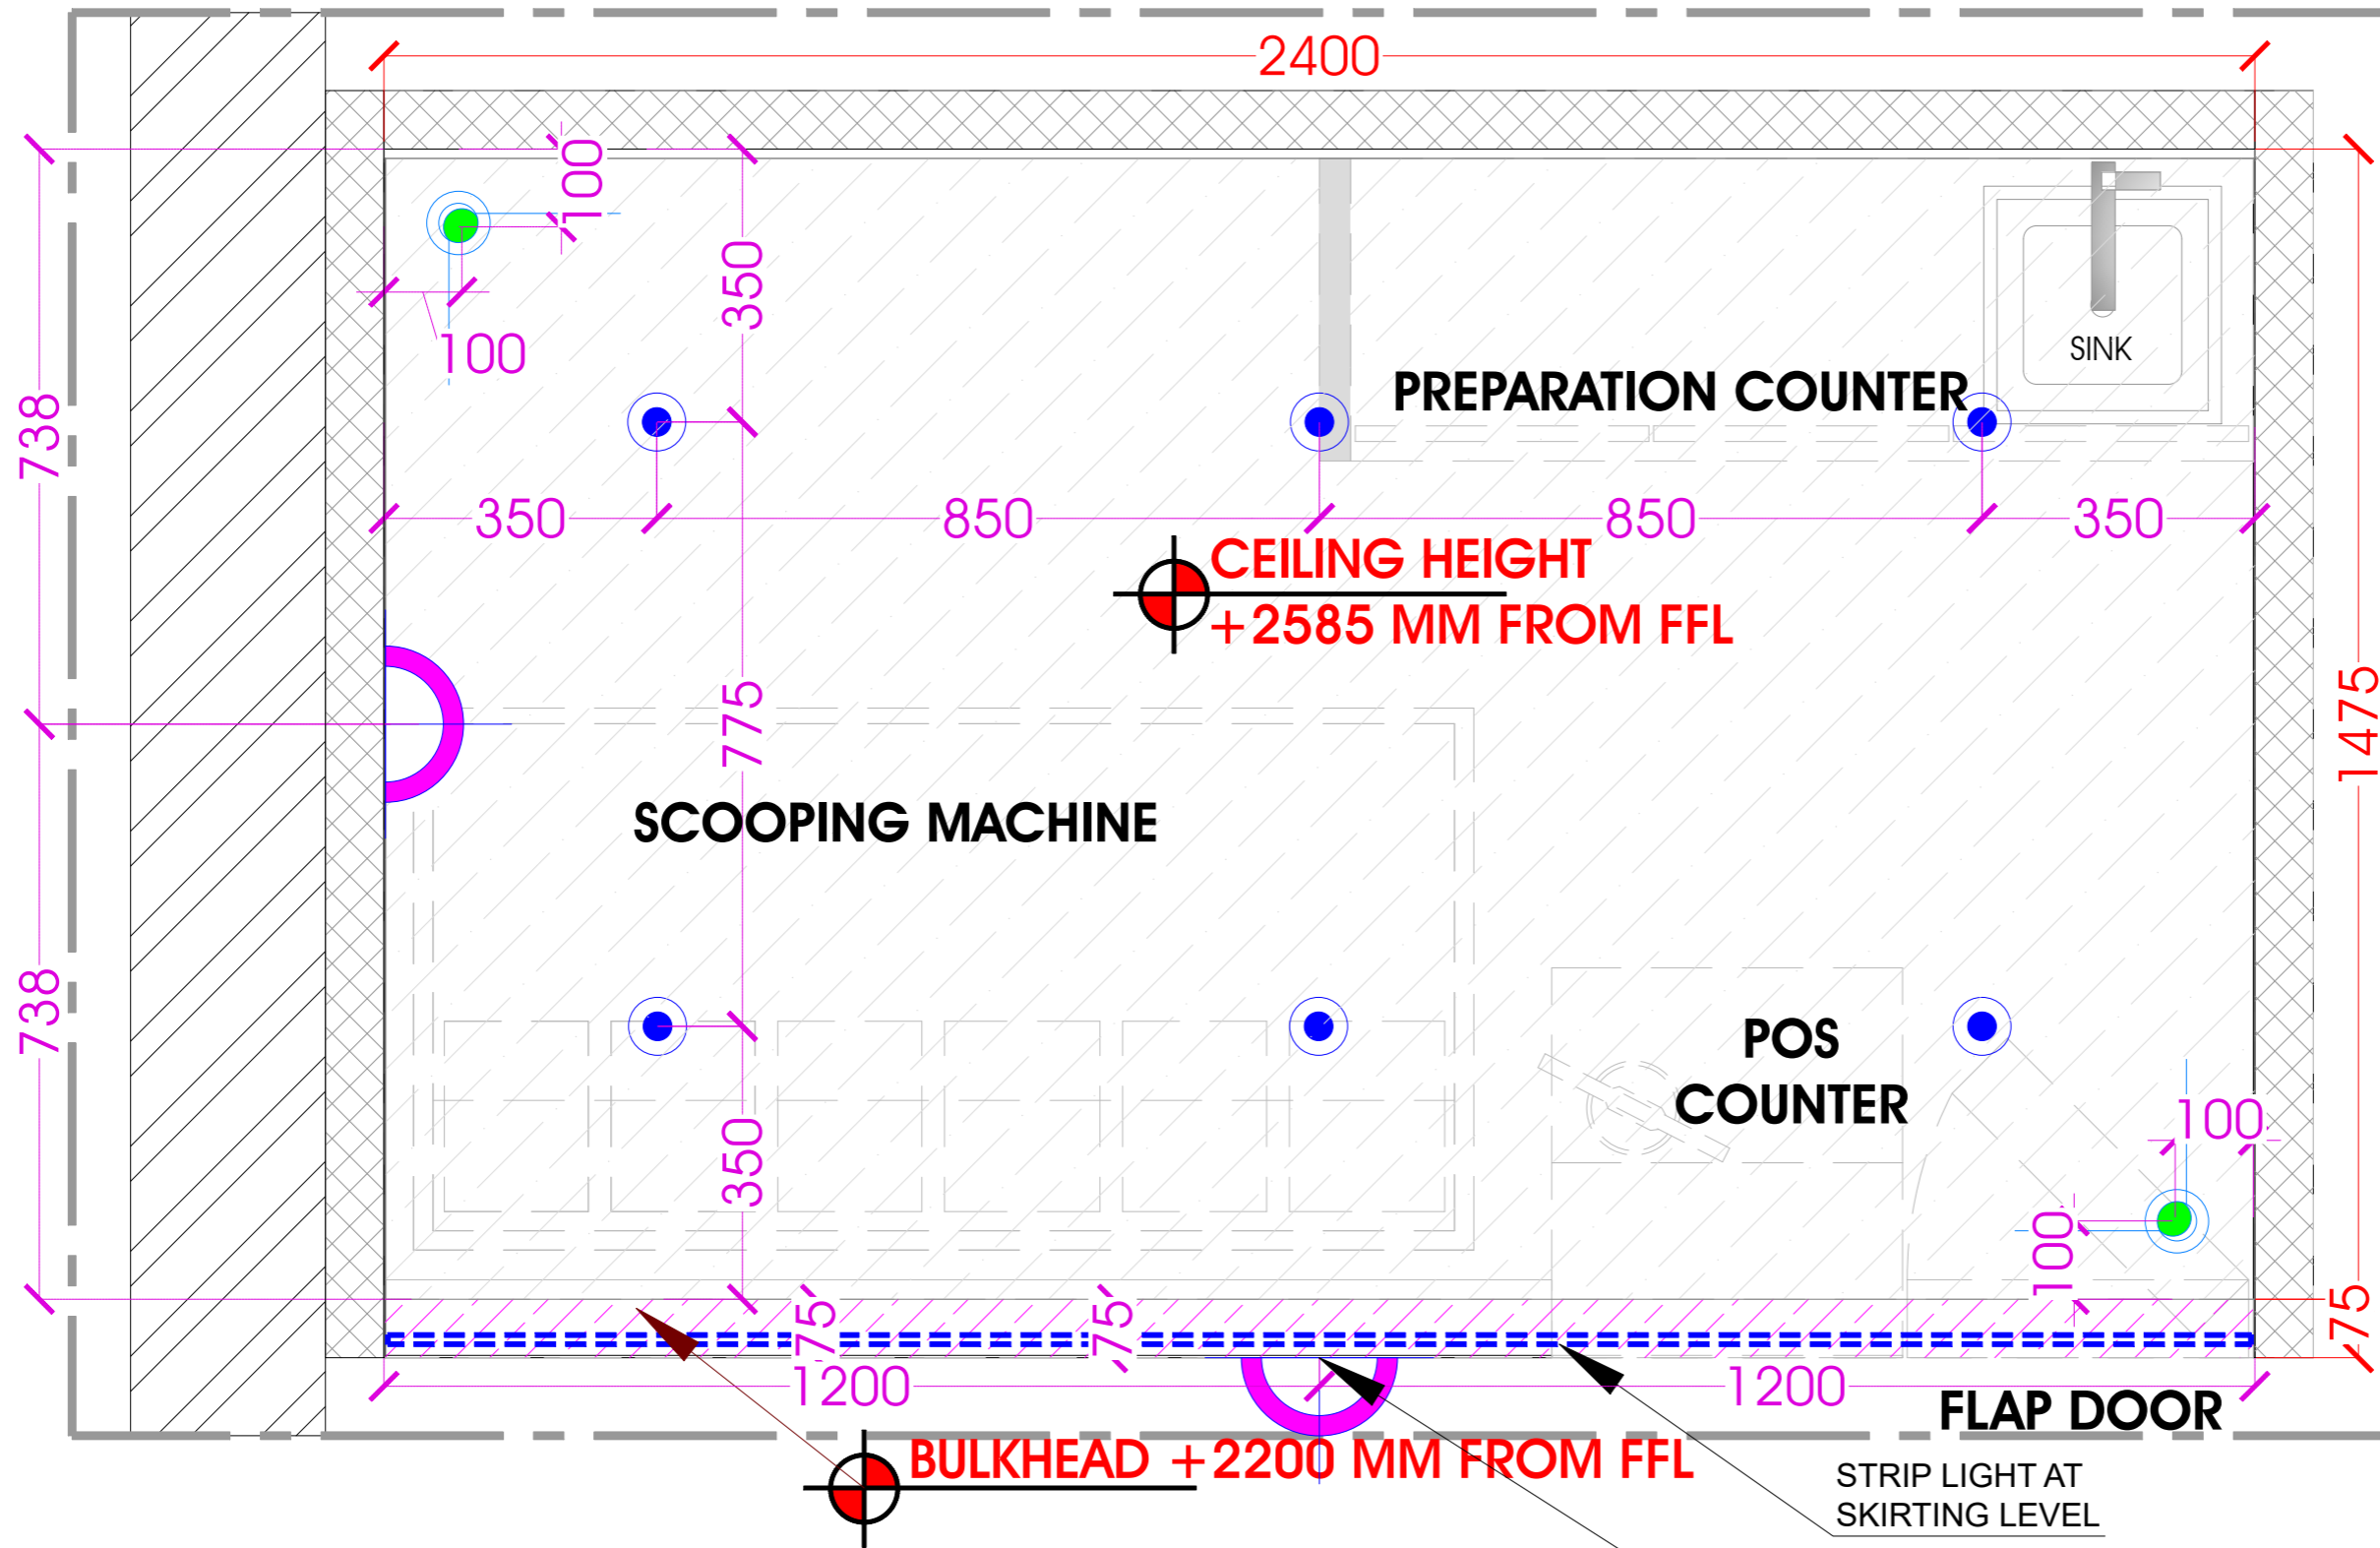AREA : AREA - 42 SQFT NORTH :



STRIP LIGHT AT SKIRTING LEVEL

NIC LIN LIT ACRYLIC SIGNAGE 3MM THK ACRYLIC ROUTER CUT WHITE FRONT & ALL SIDES IN SAME COLOR

LEGEND			LEGEND		
NOS	SYMBOL	DESCRIPTION	NOS	SYMBOL	DESCRIPTION
1		SPOT LIGHT - 12, 4000k	4		180 DEGREE DOME CAMERA
2		SIGNAGE GLOW LIGHT	5		STRIP LIGHT @ SKIRTING LEVEL

FALSE CEILING LEGEND		
INDICATION	DESCRIPTION	MATERIAL
	+2585 MM FROM FFL	GYPSUM FINISHED IN PT-01
	BULKHEAD +2200 MM FROM FFL	TL-01

FINISH LEGEND		
IMAGE	INDICATION	DESCRIPTION
	TL-01	COMPANY -NEXION SERIES -ENDLESS BIANCO SIZE - 1200MM X600MM
	PT-01	COMPANY - ASIAN PAINT CODE - 0684 Crusade-N AP Y 0914-0714M

SHEET 09 of 15

DESIGNERS : _____ Authorized Signature : _____

DRAWING SUPERVISORS : _____

PROJECT NUMBER : S-00

PROJECT NAME :

NIC ICE CREAM -
LUCKNOW AIRPORT
TERMINAL 3

DRAWING TITLE :

LOOPING LAYOUT

ISSUED / REVISION :


NO.	DATE	REMARKS
1.		
2.		
3.		
4.		
5.		

DRAWN BY : JAY P. DRAWING NO. S - 10


CHECKED BY : AMITA C.

SCALE : N T S DATE : 03-04-2024

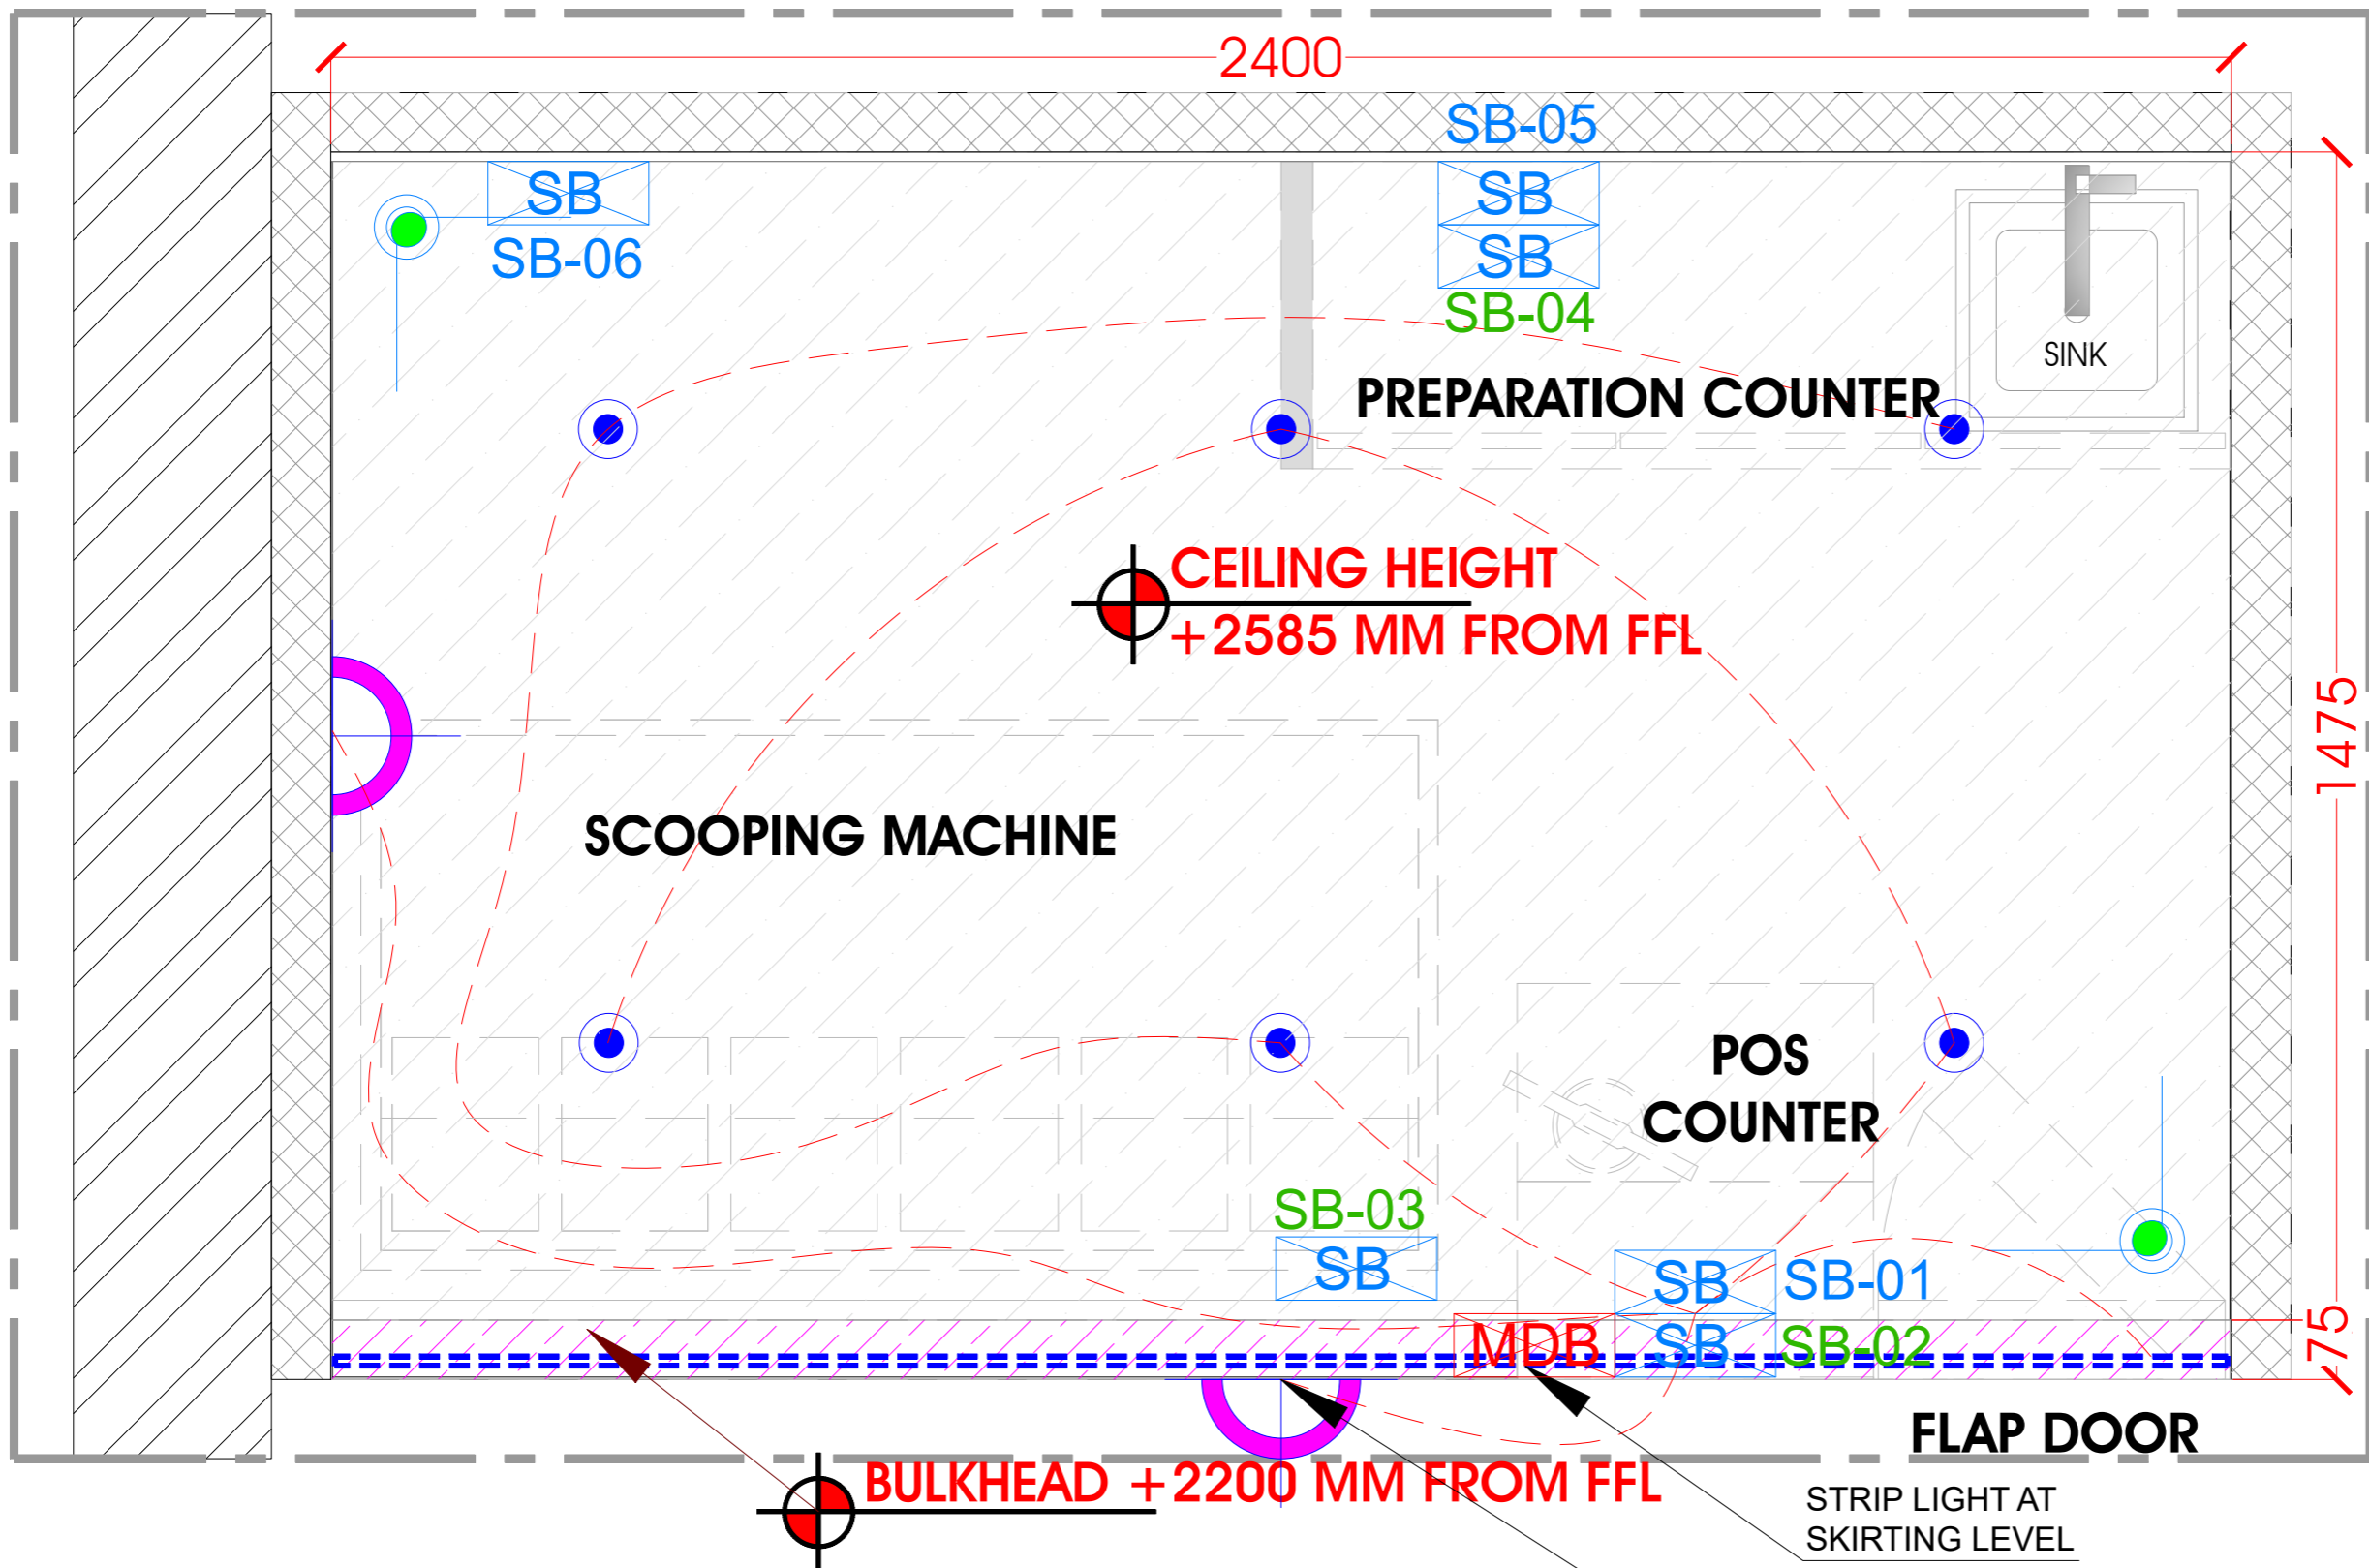AREA : AREA - 42 SQFT NORTH :



LEGEND			LEGEND		
NOS	SYMBOL	DESCRIPTION	NOS	SYMBOL	DESCRIPTION
1		SPOT LIGHT - 18W, 4000K	5		180 DEGREE DOME CAMERA
2		SIGNAGE GLOW LIGHT	6		STRIP LIGHT @ SKIRTING LEVEL
3		SWITCH BOARD	7		MAIN SWITCH (BOB@600MM)

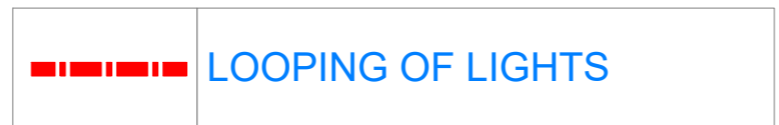

STRIP LIGHT AT SKIRTING LEVEL
NIC LIN LIT ACRYLIC SIGNAGE 3MM THK ACRYLIC ROUTER CUT WHITE FRONT & ALL SIDES IN SAME COLOR

DESIGNERS : _____ Authorized Signature : _____

DRAWING SUPERVISORS : _____

PROJECT NUMBER : _____ S-00

PROJECT NAME :

NIC ICE CREAM -
LUCKNOW AIRPORT
TERMINAL 3

DRAWING TITLE :

FIRE EXTINGUISHER LAYOUT

ISSUED / REVISION :


NO.	DATE	REMARKS
1.		
2.		
3.		
4.		
5.		

DRAWN BY : JAY P. DRAWING NO. S - 11

CHECKED BY : AMITA C.

SCALE : N T S DATE : 03-04-2024

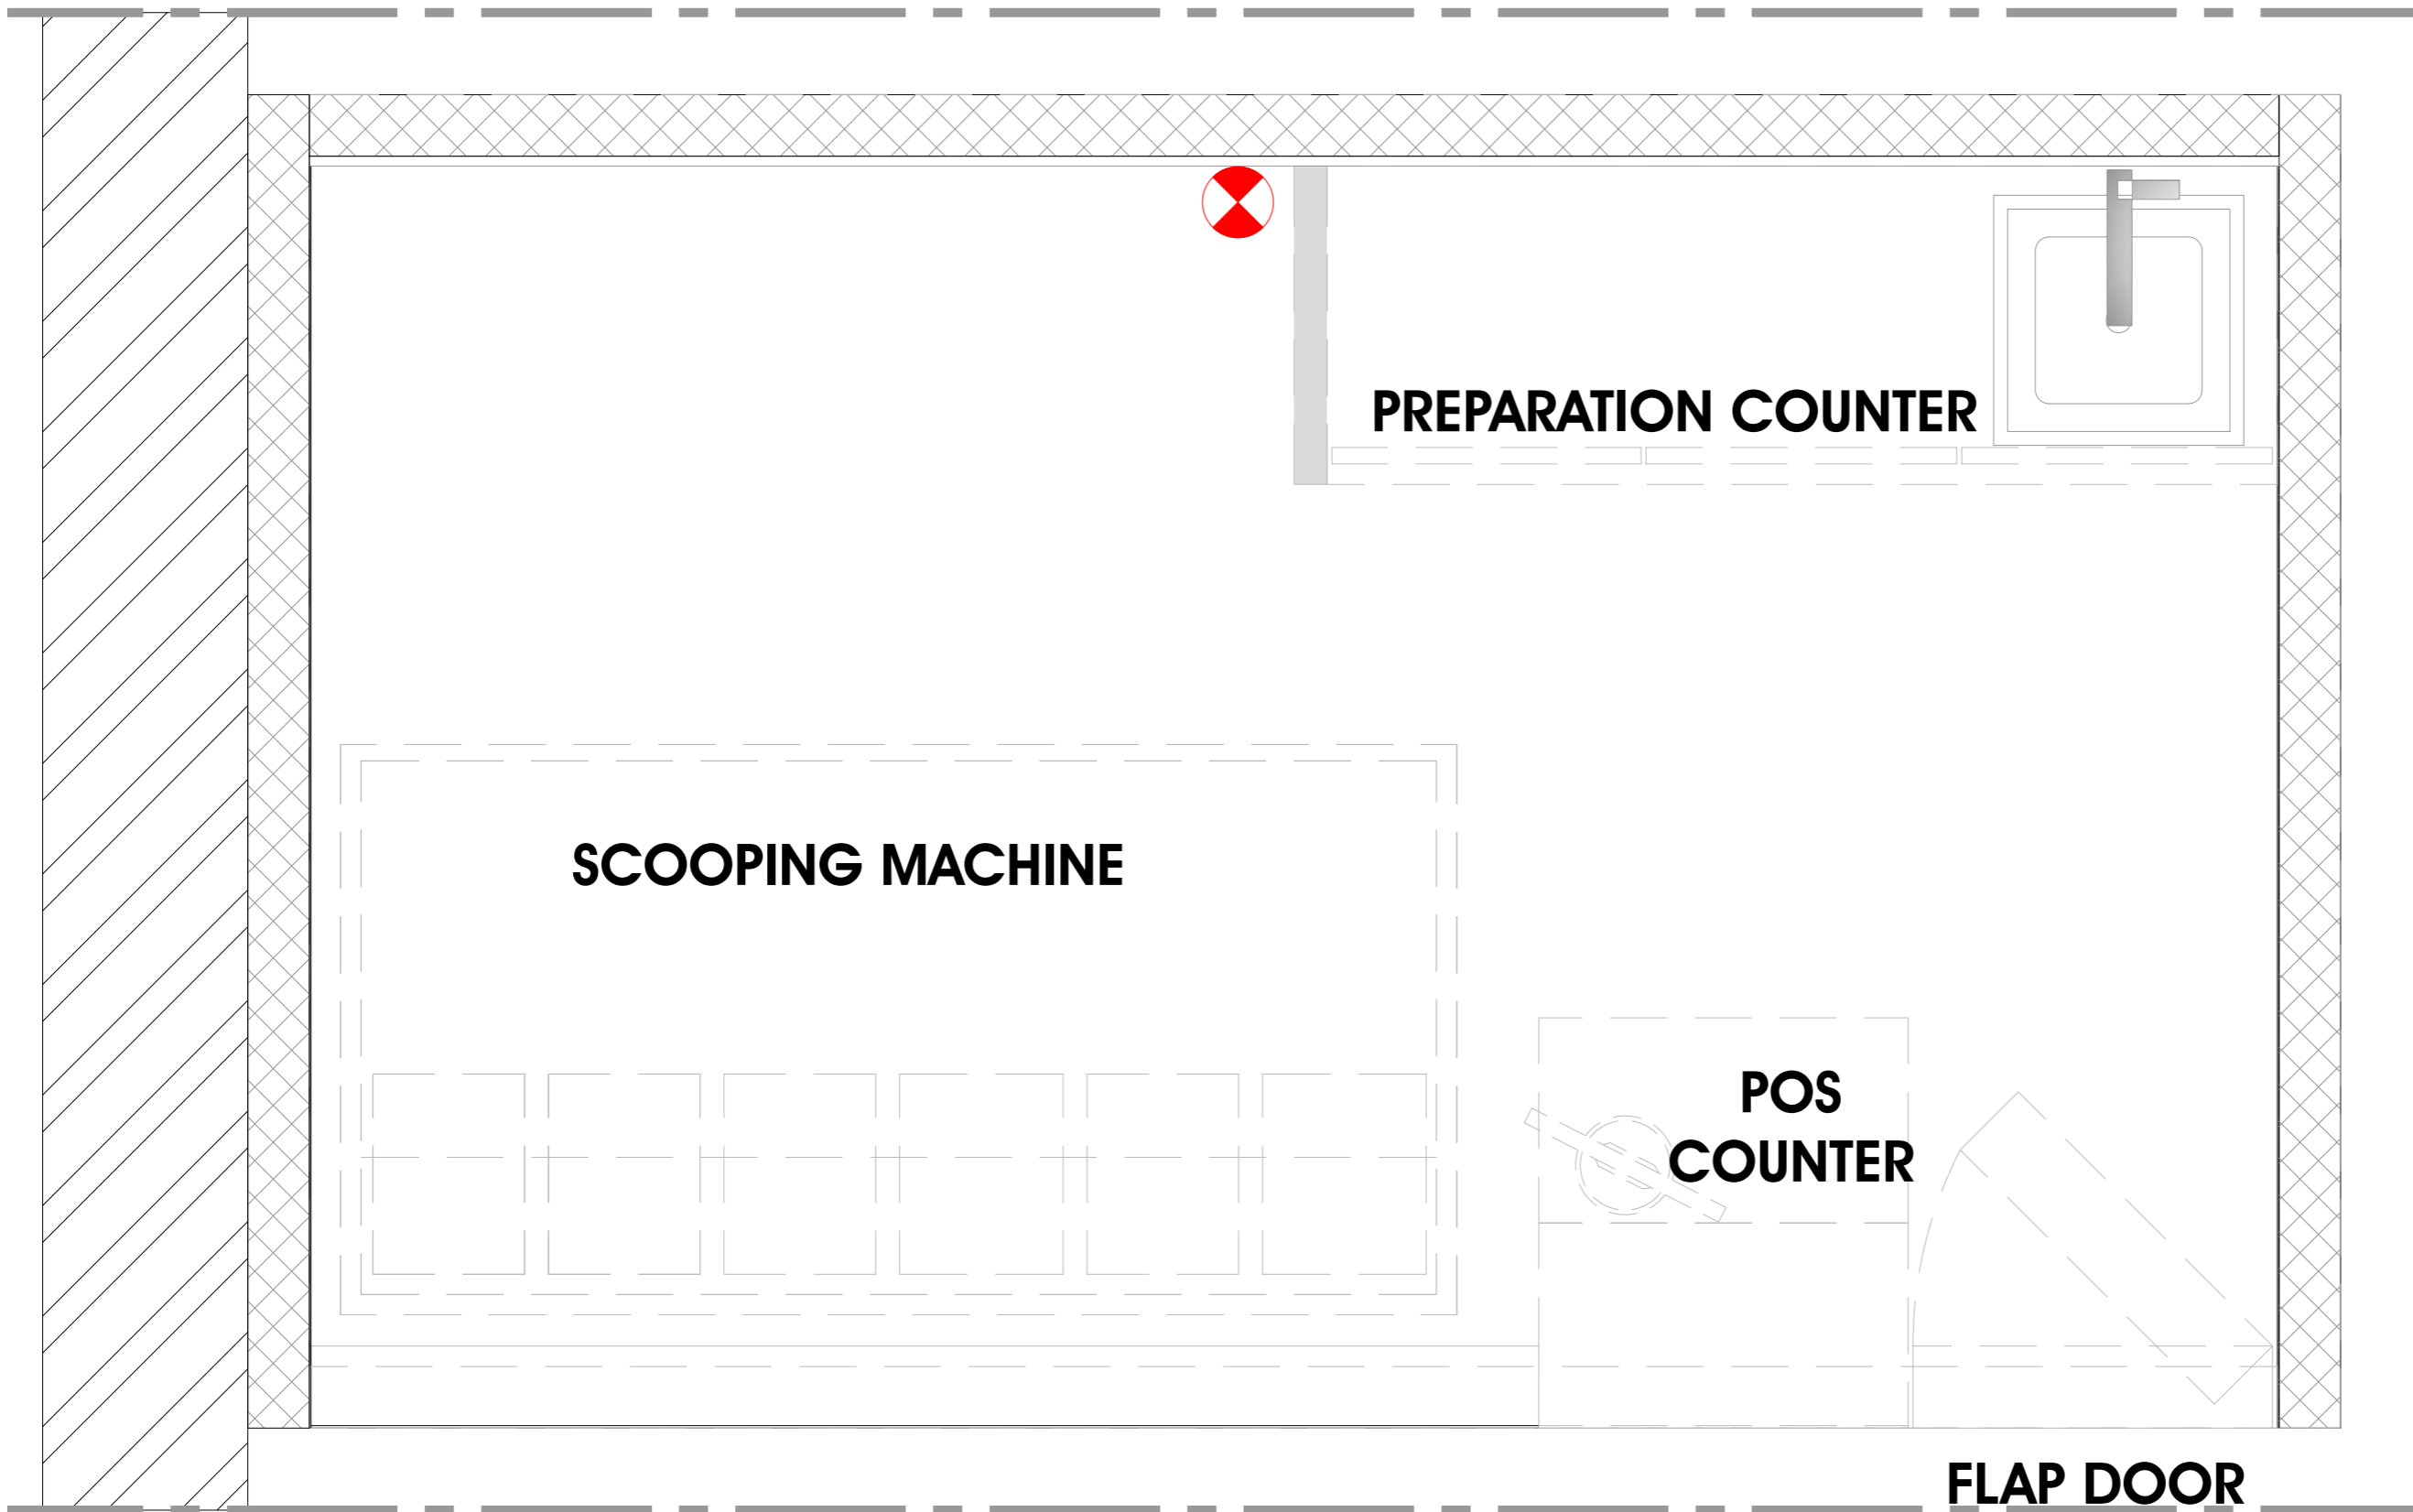AREA : AREA - 42 SQFT NORTH :



LEGEND	
SYMBOL	DESCRIPTION
	4.5 KGS CO2 PORTABLE FIRE EXTINGUISHER (ON SS STAND)

DESIGNERS : Authorized Signature :

DRAWING SUPERVISORS :

PROJECT NUMBER : S-00

PROJECT NAME :

NIC ICE CREAM -
 LUCKNOW AIRPORT
 TERMINAL 3

DRAWING TITLE :

SERVICE COUNTER DETAIL

ISSUED / REVISION :

NO.	DATE	REMARKS
1.		
2.		
3.		
4.		
5.		

DRAWN BY : JAY P.

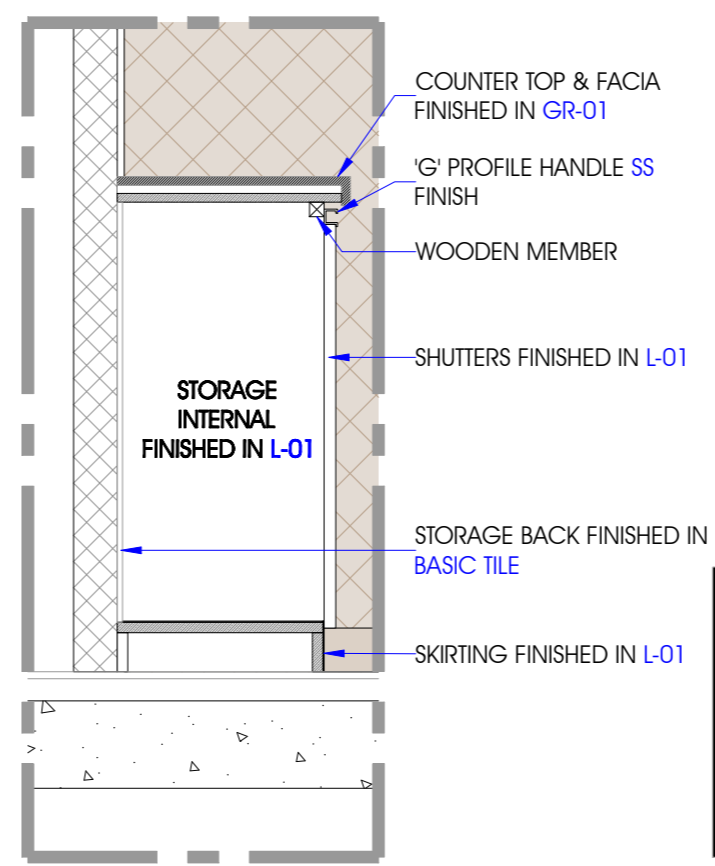
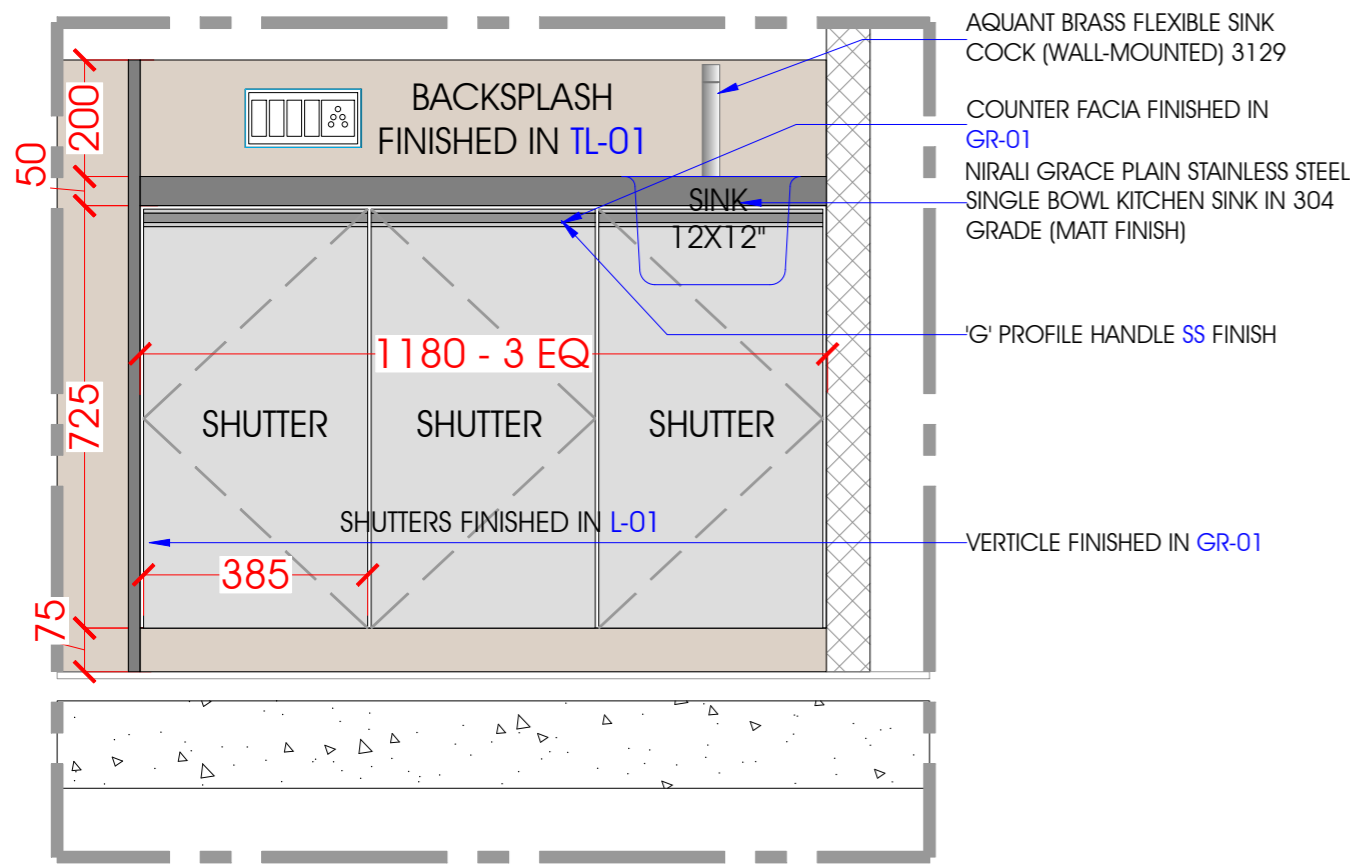
DRAWING NO.

S - 12

CHECKED BY : AMITA C.

SCALE : N T S DATE : 03-04-2024


AREA : AREA - 42 SQFT NORTH :





AQUANT BRASS FLEXIBLE SINK COCK (WALL-MOUNTED) 3129



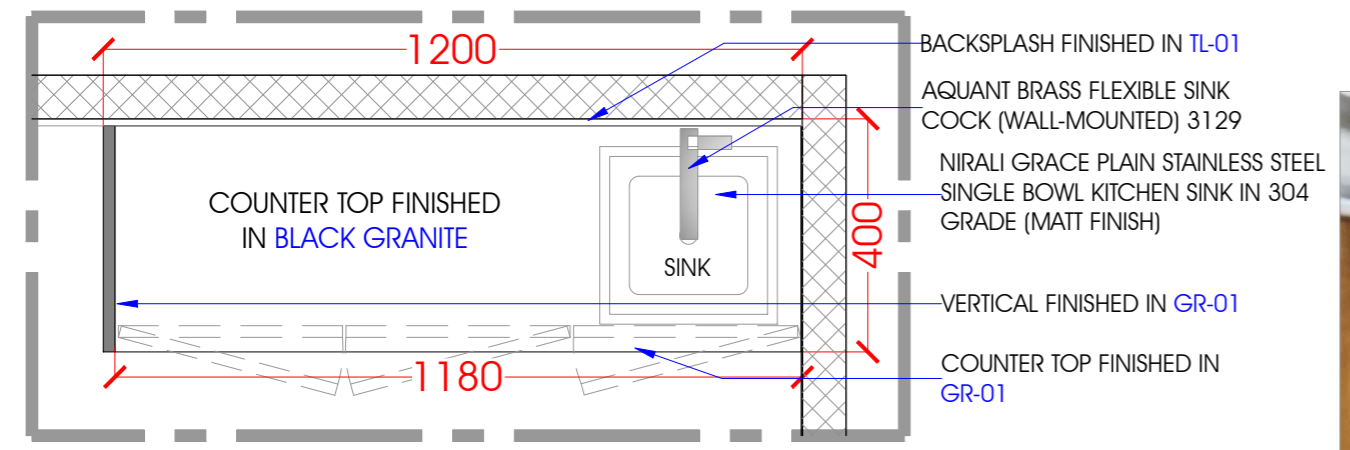NIRALI GRACE PLAIN STAINLESS STEEL SINGLE BOWL KITCHEN SINK IN 304 GRADE (MATT FINISH)



REFERENCE FOR HANDLE

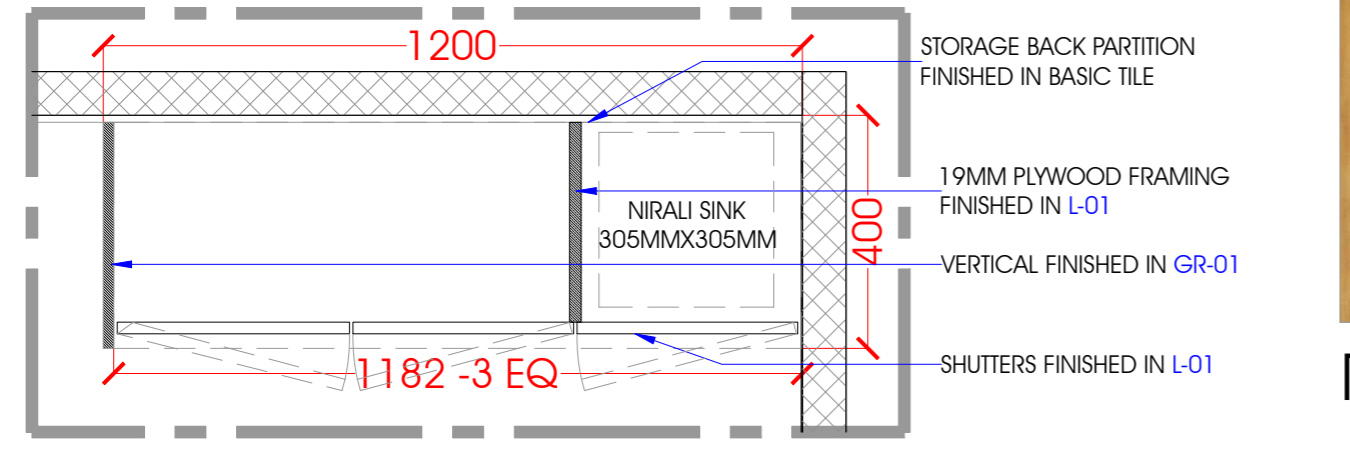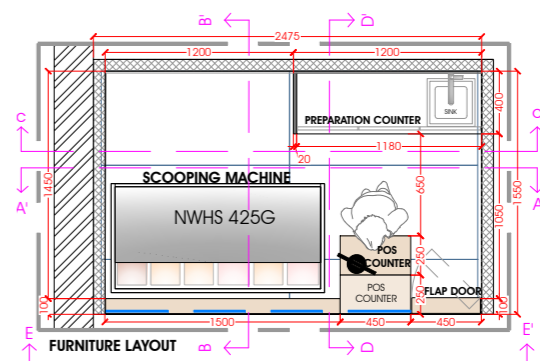

SECTIONAL PLAN

DESIGNERS : _____ Authorized Signature : _____

DRAWING SUPERVISORS : _____

PROJECT NUMBER : S-00

PROJECT NAME :

NIC ICE CREAM -
 LUCKNOW AIRPORT
 TERMINAL 3

DRAWING TITLE :

DETAILS

ISSUED / REVISION :

NO.	DATE	REMARKS
1.		
2.		
3.		
4.		
5.		

DRAWN BY : JAY P.

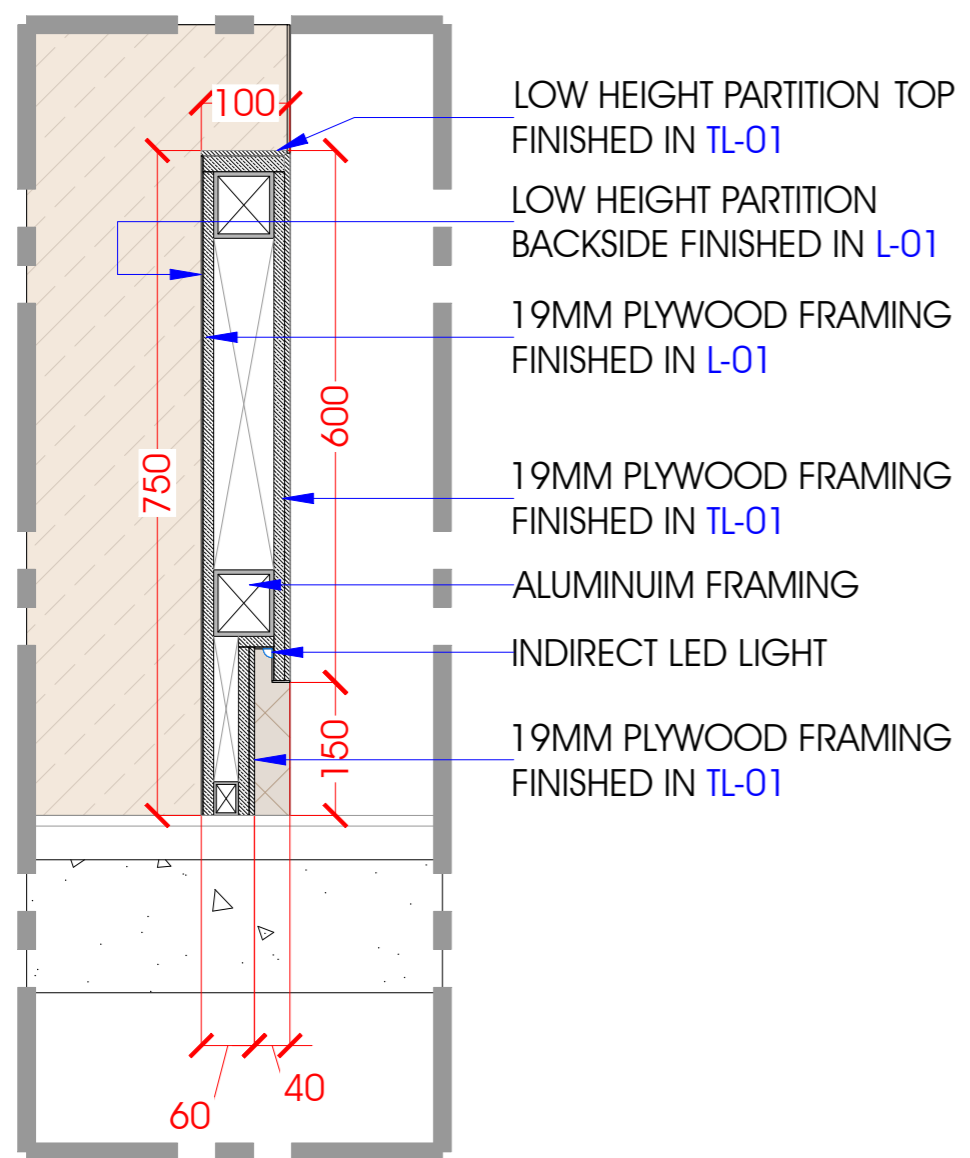
DRAWING NO.

S - 13

CHECKED BY : AMITA C.


SCALE : N T S DATE : 03-04-2024

AREA : AREA - 42 SQFT NORTH :




- LOW HEIGHT PARTITION TOP FINISHED IN TL-01
- LOW HEIGHT PARTITION BACKSIDE FINISHED IN L-01
- 19MM PLYWOOD FRAMING FINISHED IN L-01
- 19MM PLYWOOD FRAMING FINISHED IN TL-01
- ALUMINIUM FRAMING
- INDIRECT LED LIGHT
- 19MM PLYWOOD FRAMING FINISHED IN TL-01

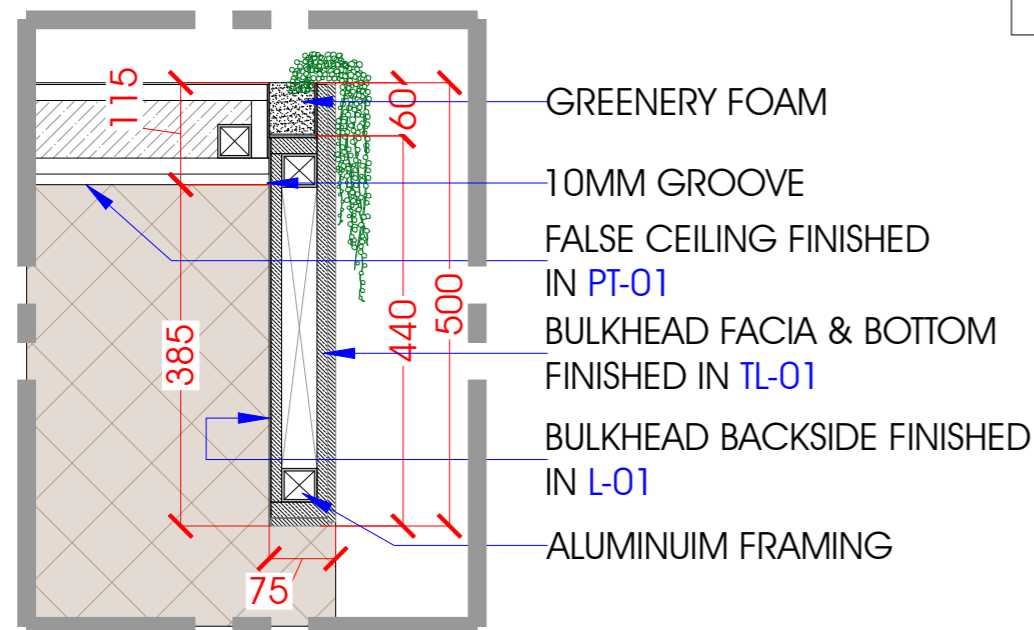DETAIL - A




- GREENERY FOAM
- 10MM GROOVE
- FALSE CEILING FINISHED IN PT-01
- BULKHEAD FACIA & BOTTOM FINISHED IN TL-01
- BULKHEAD BACKSIDE FINISHED IN L-01
- ALUMINIUM FRAMING

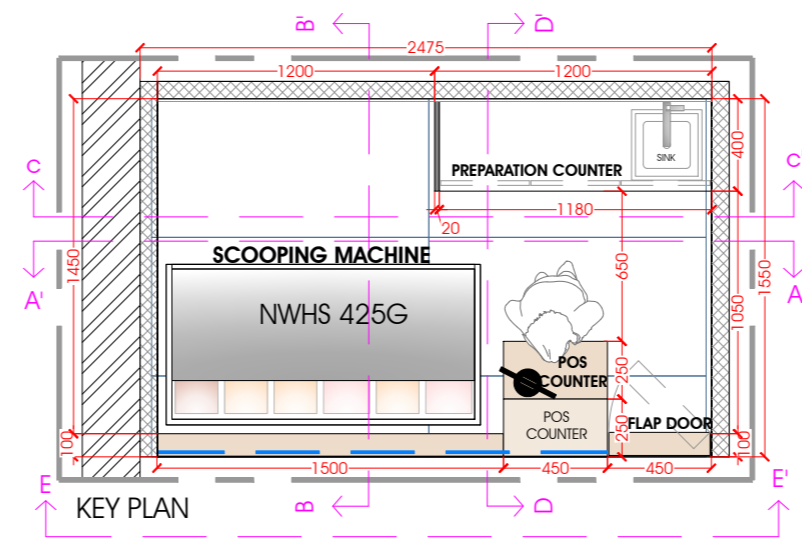DETAIL - B




FINISH LEGEND		
IMAGE	INDICATION	DESCRIPTION
	TL-01	COMPANY - NEXION SERIES - ENDLESS BIANCO SIZE - 1200MM X600MM
	PT-01	COMPANY - ASIAN PAINT CODE - 0684 Crusade-N AP Y 0914-0714M
	PT-02	COMPANY - ASIAN PAINT CODE - L161 ABSOLUTE WHITE
	L-01	COMPANY - GREENLAM LAMINATES SERIES - 2020_2022 COLLECTION CODE - 133 SUD MOON STONE
	L-02	COMPANY - GREENLAM LAMINATES SERIES - 2020_2022 COLLECTION CODE - 101 SGL WHITE
	GR-01	BLACK GRANITE
	M-01	5/6MM GREY TINTED MIRROR (EDGE TO BE MACHINE POLISHED)

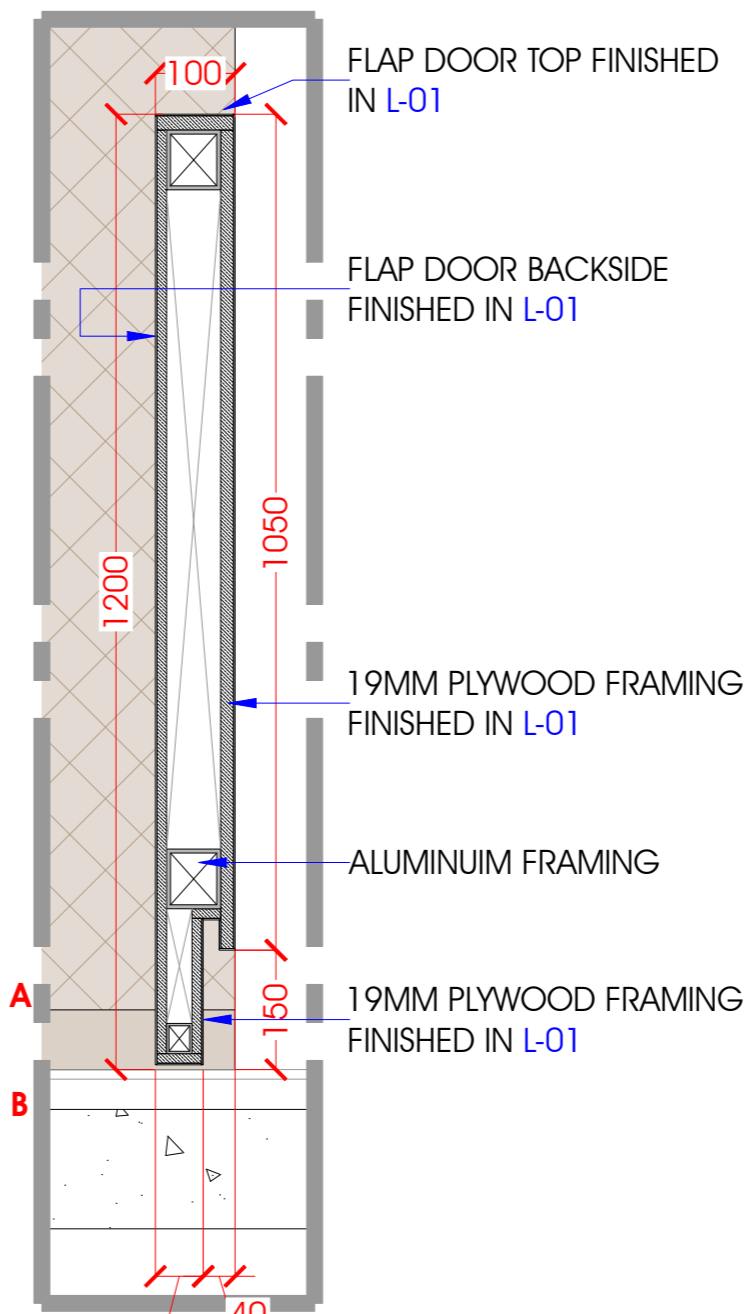

- FLAP DOOR TOP FINISHED IN L-01
- FLAP DOOR BACKSIDE FINISHED IN L-01
- 19MM PLYWOOD FRAMING FINISHED IN L-01
- ALUMINIUM FRAMING
- 19MM PLYWOOD FRAMING FINISHED IN L-01

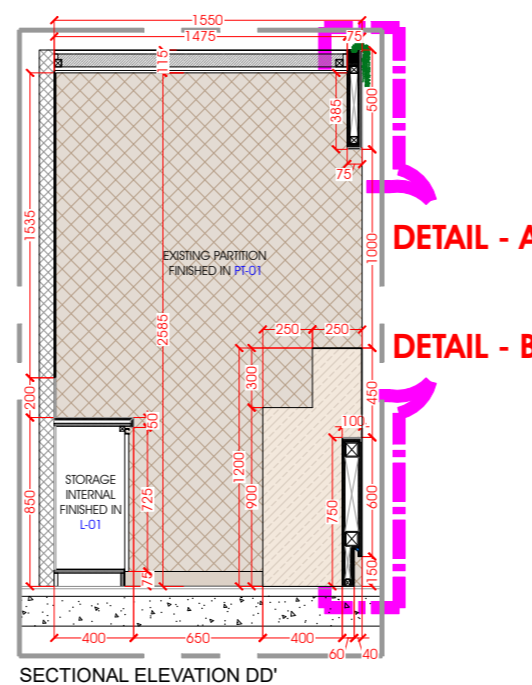DETAIL - C (FLAP DOOR)



SECTIONAL ELEVATION DD'

DESIGNERS : _____
 Authorized Signature : _____

DRAWING SUPERVISORS : _____

PROJECT NUMBER : S-00

PROJECT NAME :

NIC ICE CREAM -
 LUCKNOW AIRPORT
 TERMINAL 3

DRAWING TITLE :

SIGNAGES

ISSUED / REVISION :

NO.	DATE	REMARKS
1.		
2.		
3.		
4.		
5.		

DRAWN BY :

JAY P.

DRAWING NO.

S - 14

CHECKED BY :

AMITA C.

SCALE :

N T S

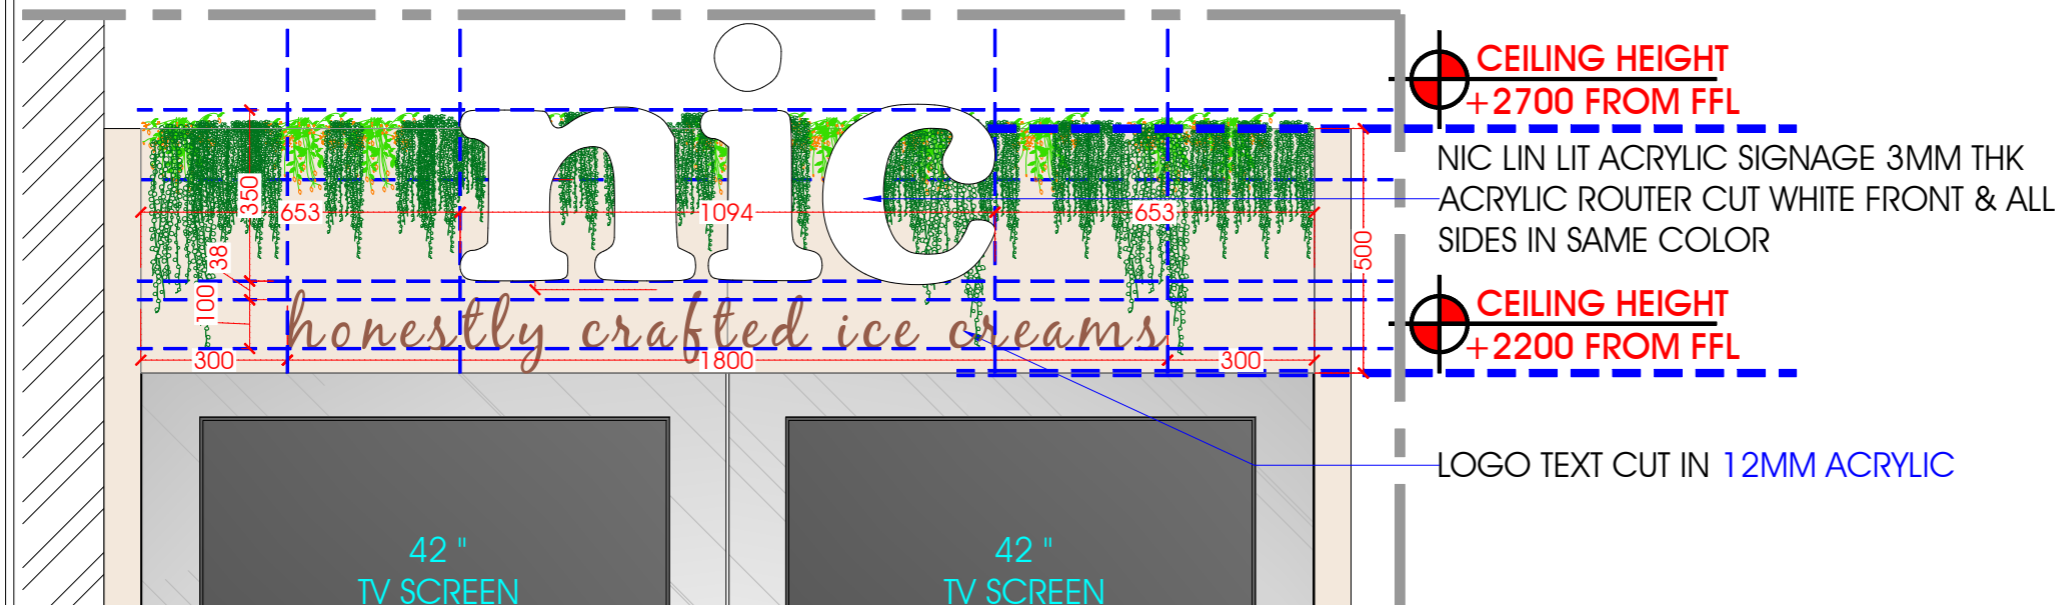
DATE :

03-04-2024

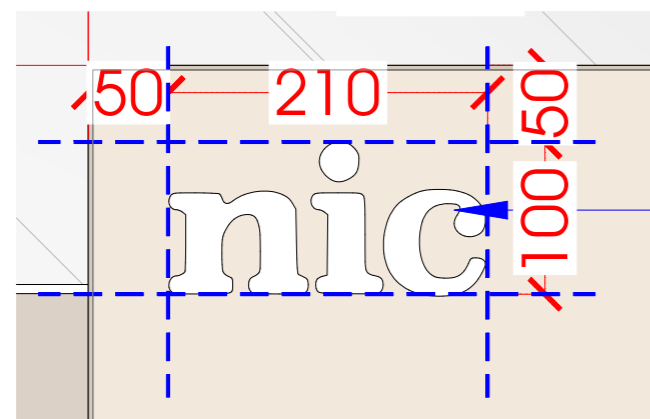
AREA :

AREA - 42 SQFT

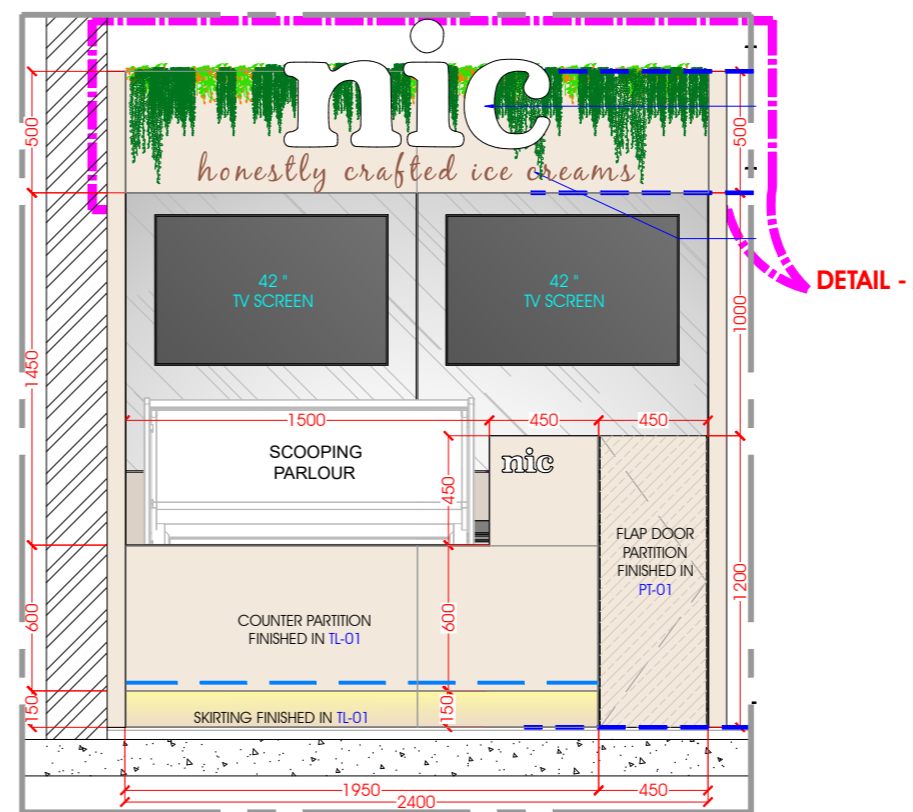
NORTH :




 

SIGNAGE DETAIL - A (GL-01 & AL-01)



SIGNAGE DETAIL - B (AL-02)



SECTIONAL ELEVATION EE'

SIGNAGE LEGEND		
IMAGE	INDICATION	DESCRIPTION
	GL-01	NIC LIN LIT ACRYLIC SIGNAGE 3MM THK ACRYLIC ROUTER CUT WHITE FRONT & ALL SIDES IN SAME COLOR
	AL-01	LOGO TEXT CUT IN ACRYLIC FONT - BLACK JACK HEIGHT - 100MM WIDTH(THICKNESS) - 12MM
	AL-02	LOGO TEXT CUT IN ACRYLIC HEIGHT - 100MM WIDTH(THICKNESS) - 12MM

DESIGNERS : _____ Authorized Signature : _____

DRAWING SUPERVISORS : _____

PROJECT NUMBER : _____ S-00

PROJECT NAME :

NIC ICE CREAM -
 LUCKNOW AIRPORT
 TERMINAL 3

DRAWING TITLE :

MATERIAL LIST

ISSUED / REVISION :

NO.	DATE	REMARKS
1.		
2.		
3.		
4.		
5.		



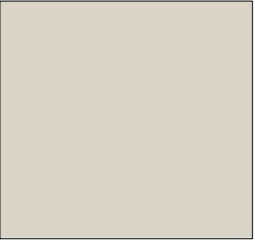



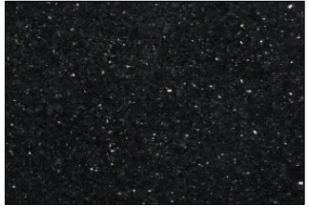
DRAWN BY : JAY P. DRAWING NO. **S - 15**

CHECKED BY : AMITA C.

SCALE : N T S DATE : 03-04-2024

AREA : AREA - 42 SQFT NORTH :

MATERIAL LEGEND

IMAGE	INDICATION	DESCRIPTION	IMAGE	INDICATION	DESCRIPTION
	TL-01	COMPANY -NEXION SERIES -ENDLESS BIANCO SIZE - 1200MM X600MM		-	CATALOGUE NAME - VESTERIA BRAND - HOME DECOR NAME - TINY FLOWER WITH LILY HANGING CREEPER HEIGHT - 500 MM
	PT-01	COMPANY - ASIAN PAINT CODE - 0684 Crusade-N AP Y 0914-0714M		-	BRAND -NIRALI GRACE PLAIN STAINLESS STEEL SINGLE BOWL KITCHEN SINK IN 304 GRADE (MATT FINISH) 305MM X 305MM
	L-01	COMPANY - GREENLAM LAMINATES SERIES - 2020_2022 COLLECTION CODE - 133 SUD MOON STONE		-	BRAND - AQUANT MODEL - BRASS FLEXIBLE SINK COCK (WALL-MOUNTED) 3129
	GR-01	BLACK GRANITE			
	M-01	5/6MM GREY TINTED MIRROR (EDGE TO BE MACHINE POLISHED)			