


PROJECT
AIRPORT,
DELHI

CLIENT
TACO BELL

NOTE:
THIS DRAWING & DESIGN IS THE COPYRIGHT OF THE DESIGNER. NO PORTION MAY BE REPRODUCED WITHOUT THE WRITTEN PERMISSION OF THE DESIGNERS

1. ALL DIMENSIONS ARE INCLUDING FINISHES
2. DO NOT SCALE DRAWING. ONLY MENTIONED DIMENSIONS ARE TO BE CONSIDERED.
3. ALL DIMENSIONS MUST BE CHECKED BEFORE COMMENCING WORK ON SITE.
4. ANY DISCREPANCIES SHALL BE BROUGHT UNDER THE NOTICE OF ARCHITECTS PRIOR COMMENCEMENT OF WORK.

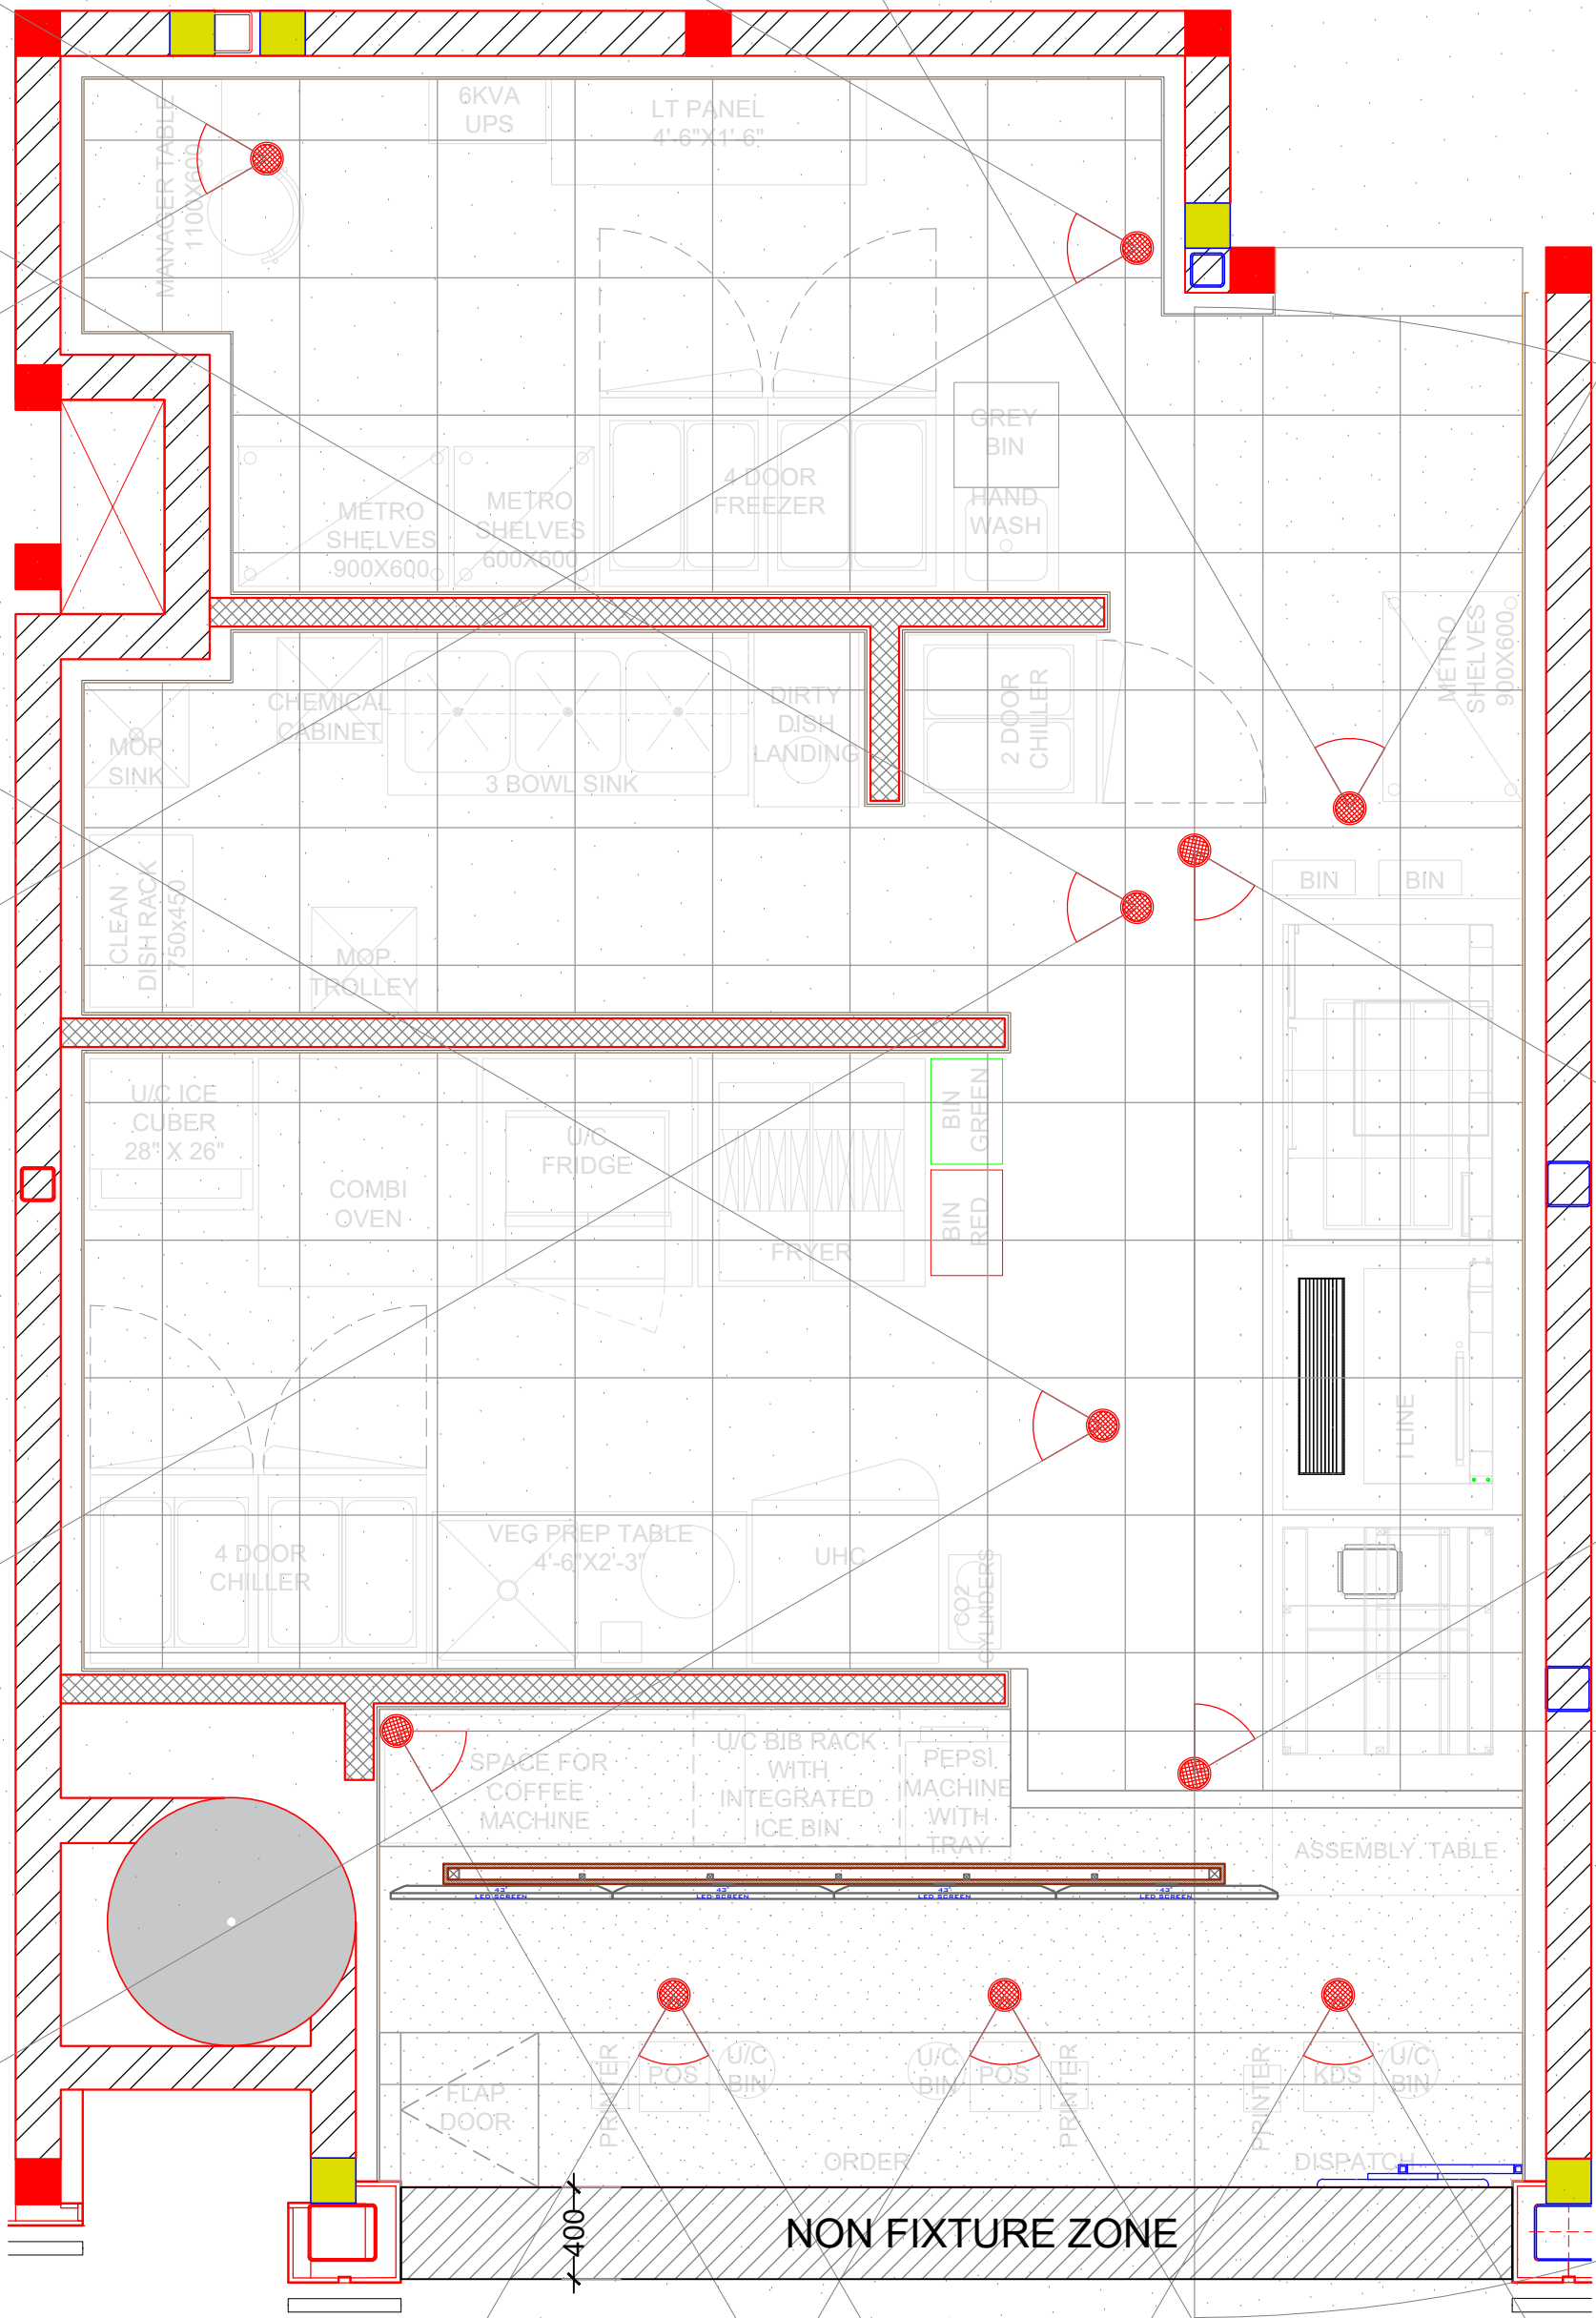

CCTV LEGEND

LEGEND	DESCRIPTION	QTY.
	CCTV CAMERA'S NIGHT VISION WITH 21'-0" RANGE	15+1
	DVR WITH PC	01
	MONITOR	01

REVISION

S.NO.	REMARKS	DATE
1	REV 1	00/00/00
2	REV 2	00/00/00
3	REV 3	00/00/00
4	REV 4	00/00/00
5	REV 5	00/00/00
6	REV 6	00/00/00
7	REV 7	00/00/00
8	REV 8	00/00/00

ARCHITECT / INTERIOR DESIGN

ARCHITECTURE PLANNING
INTERIOR FURNITURE

FLAT NO-13 DDA SFS
SLAT POCKET -1 SEC-6 DWARKA,
NEW DELHI-110075
EMAIL:-info@ankitstudio@gmail.com
OFF-011-35559249, MOB-9910315171

CONSULTANT

CONSULTANT

RELEASE FOR
INFORMATION | TENDER | CONSTRUCTION | AS BUILT

TITLE
CCTV LAYOUT

DATE	19-10-2023
SCALE	NTS
DRAWN BY	ANKITA
CHECKED BY	AR. ANKIT
PRINTED BY	-
DWG. NO.	WD-D-23