



C01 19.02.24 GOOD FOR CONSTRUCTION HOD NM  
REV DATE DESCRIPTION DRN CHK

LIST OF DRAWINGS		
#	DESCRIPTION	DWG.No
1	COVER SHEET	02GA-001
2	APPROVED VISUALS	02GA-002
3	GENERAL NOTES & FINISHES SHEDULE	02GA-003
4	FURNITURE , LIGHT & FIXTURE LEGEND	02GA-004
5	DETAIL DRAWING LEGEND	02GA-005
PLANS		
6	GENERAL ARRANGEMENT PLAN	02GA-100
7	EQUIPMENT LAYOUT	02GA-101
8	W ALL DETAIL LAYOUT	02GA-102
9	SETTING OUT PLAN	02GA-103
10	RCP+LIGHTING LAYOUT-PART:A	02GA-104
11	RCP+LIGHTING LAYOUT-PART:B	02GA-105
12	FLOORING LAYOUT	02GA-106
13	WATER PROOFING LAYOUT	02GA-107
14	FINISHES PLAN	02GA-108

ELEVATIONS & SECTIONS		
15	ELEVATION-01	03IL-300
16	ELEVATION-02	03IL-301
17	ELEVATION-03	03IL-302
18	ELEVATION-04	03IL-303
19	SECTION-01	03IL-304
DETAIL DRAWINGS		
20	J01-FRONT COUNTER DETAIL-PART:A	04DE-400
21	J01-FRONT COUNTER DETAIL-PART:B	04DE-401
22	J02-REAR COUNTER-01 DETAIL	04DE-402
23	J03-REART COUNTER-02 DETAIL	04DE-403
24	J04-COMMUNITY TABLE DETAIL	04DE-404
25	J05-BULKHEAD DETAIL-PART:A	04DE-405
26	J05-BULKHEAD DETAIL-PART:B	04DE-406
27	J06-SERVICE CLOSET DETAIL	04DE-407
28	J07-BAFFLE CEILING DETAIL	04DE-408
29	J08-SIGNAGE DETAIL	04DE-409



PROJECT  
FF-045  
MILIE COOKIES  
HYDERABAD AIRPORT

DRAWING TITLE  
COVER SHEET

SCALE NTS DATE 19.02.2024 DRAWN HOD A3 SHEET

STATUS  
GOOD FOR CONSTRUCTION


ORG PROJECT NO DRAWING TYPE NUMBER REV  
TFS XXXX 02GA 001 C01



VIEW-01



VIEW-02

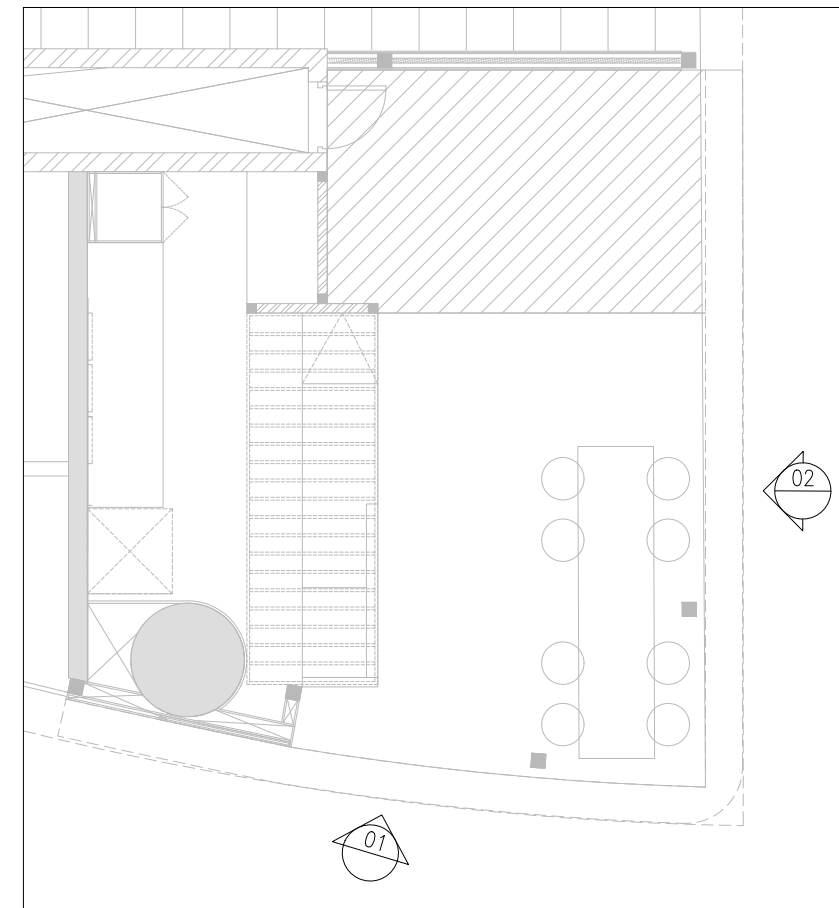

KEY PLAN

REV	DATE	DESCRIPTION	HOD	NM
C01	19.02.24	GOOD FOR CONSTRUCTION		



PROJECT  
FF-045  
MILIE COOKIES  
HYDERABAD AIRPORT

DRAWING TITLE  
APPROVED VISUALS

SCALE NTS DATE 19.02.2024 DRAWN HOD A3 SHEET

STATUS  
GOOD FOR CONSTRUCTION

ORG	PROJECT NO	DRAWING TYPE	NUMBER	REV
TFS	XXXX	02GA	002	C01

**GENERAL NOTES**

ALL DIMENSIONS ARE IN MM UNLESS OTHERWISE MENTIONED.  
DO NOT SCALE THE DRAWING.

FOLLOW WRITTEN DIMENSIONS ONLY. IN CASE OF ANY DISCREPANCY IN DIMENSIONS/DETAILS AT SITE, PLEASE REFER IT BACK TO THE ARCHITECT.

THE MAIN CONTRACTOR IS EXPECTED TO COORDINATE THE DESIGNS/SITE EXECUTION WITH THE DESIGNS/DETAILS/WORKS OF THE SUB-CONTRACTOR/ VENDOR (E.G. PLUMBING CONTRACTOR). IN CASE OF ANY DISCREPANCY IN DIMENSIONS/DETAILS AT SITE, PLEASE REFER IT BACK TO THE ARCHITECT.


THE DRAWINGS/ DETAILS PROVIDED ARE MEANT TO CLARIFY DESIGN INTENT/DESIGN APPEARANCE ONLY. THE CONTRACTOR IS EXPECTED TO DEVELOP HIS/HER OWN DETAILS TO ENSURE STRUCTURAL STABILITY/ FUNCTIONING OF THE DETAIL IN LINE WITH THE DESIGN INTENT GIVEN.

THE DRAWINGS/DETAILS PROVIDED DO NOT CONTAIN ANY IRONMONGERY (E.G. HINGES, SCREWS, ANGLES ETC.) SPECIFICATIONS OR DETAILS. IT IS EXPECTED THE CONTRACTOR WILL SUITABLY DETAIL THE BUILD-UPS WITH THE RIGHT FITTINGS/IRONMONGERY TO ENSURE STRUCTURAL STABILITY/ FUNCTIONING OF THE DETAIL IN LINE WITH THE DESIGN INTENT GIVEN.

ALL SHOP DRAWINGS, MAKE/MATERIAL, FIXTURES TO BE PRESENTED TO ARCHITECT FOR REVIEW AND VALIDATION.

ALL TAP-OFF POINTS (E.G. FOR POWER, WATER, DRAINAGE ETC.) TO BE VALIDATED AT SITE PRIOR TO COMMENCEMENT OF WORK.

**SYMBOLS & ABBREVIATIONS**

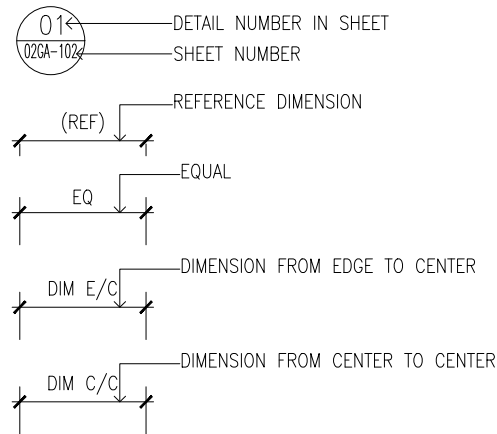

ALL DIMENSIONS MUST BE CHECKED ON SITE  
INFORM THE ARCHITECT OF ANY DISCREPANCIES PRIOR TO CONSTRUCTION

FINISHES SCHEDULE								
#	FINISH CODE	SURFACE	FINISH TYPE	DESCRIPTION/DETAIL	FINISH	REFERENCE/BRAND	WEBLINK	IMAGE
<b>PAINT</b>								
1	PT01	CHARCOAL PANEL(FRONT COUNTER FASCIA & BULKHEAD), MDF PANEL, WALL, GYPSUM CEILING	EMULSION	WHITE COLOUR PAINT	MATTE	DULUX TRADE PAINT/EQUIVALENT	<a href="https://www.dulux.co.uk/en/products/duluxsofts/bsen/colour_1935922?size=7.5#tabid=reviews">https://www.dulux.co.uk/en/products/duluxsofts/bsen/colour_1935922?size=7.5#tabid=reviews</a>	
2	PT02	BAFFLE C BLING, COMMUNITY TABLE(METAL FRAME), ALUMINIUM LOUVER(SERVICE CLOSET)	ENAMEL	WHITE COLOUR PAINT	MATTE	DULUX TRADE PAINT/EQUIVALENT	<a href="https://www.duluxtradepaints.co.uk/en/products/dulux-trade-metalshield-satin/colour_1780570?size=2.5L">https://www.duluxtradepaints.co.uk/en/products/dulux-trade-metalshield-satin/colour_1780570?size=2.5L</a>	
<b>LAMINATE</b>								
3	LM01	COMMUNITY TABLE, SWING DOOR, SERVICE CLOSET	LAMINATE	WHITE COLOUR LAMINATE	MATTE	CENTURY-WHITE CODE:101	<a href="https://www.centuryply.com/centurylaminates/single.php?productid=179&amp;product-name=white&amp;cat=any-white&amp;sku=101">https://www.centuryply.com/centurylaminates/single.php?productid=179&amp;product-name=white&amp;cat=any-white&amp;sku=101</a>	
4	LM02	INSIDE FASCIA(FRONT & REAR COUNTER -01,02, SERVICE CLOSET)&REAR COUNTER - 01 & 02 FASCIA, FRONT COUNTER(REAR FASCIA)	LAMINATE	GREY COLOUR LAMINATE	MATTE	CENTURY-GREY CODE:80232	<a href="https://www.centuryply.com/centurylaminates/single.php?productid=562">https://www.centuryply.com/centurylaminates/single.php?productid=562</a>	
<b>METAL</b>								
5	MT01	SKIRTING	STAINLESS STEEL	STAINLESS STEEL	MATTE	LOCALLY SOURCED	NA	
<b>COUNTER TOP</b>								
6	SU01	FRONT COUNTER, REAR COUNTER 01 & 02	CORIAN	SPARKLING GRANITA CORIAN TOP	MATTE	CORIAN® SOLID SURFACE SPARKLING GRANITA	<a href="https://coriandesigns.com/usa/enr/usa/products/coriansolid-surface-sparkling-granita/">https://coriandesigns.com/usa/enr/usa/products/coriansolid-surface-sparkling-granita/</a>	
<b>CHARCOAL PANEL</b>								
7	CP01	BULKHEAD & FRONT COUNTER	CHARCOAL PANEL	EMBOSSED CHARCOAL PANEL FINISH WITH WHITE COLOUR PAINT(PT01)	MATTE	LOCALLY SOURCED	NA	
<b>FLOORING</b>								
8	FL01	FLOOR (SEATING AREA)	CONCRETE	POLISHED CONCRETE	MATTE	LOCALLY SOURCED	NA	
9	FL02	FLOOR (SEATING AREA)	PORCELAIN TILE	300X300MM PATTERNED PORCELAIN TILE	MATTE	ROYAL TILES /EQUIVALENT	<a href="https://royaltiles.com/boutiqueusa/">https://royaltiles.com/boutiqueusa/</a>	
10	FL03	FLOOR (SERVRY)	CERAMIC TILE	600X600MM GREY COLOUR KOTA STONE	MATTE	SIMPOLO-SOLID DOVE, SOLID ASH/EQUIVALENT	<a href="https://www.simpolo.net/product-detail/minimo/minimo-collection/solid-dove_solidash">https://www.simpolo.net/product-detail/minimo/minimo-collection/solid-dove_solidash</a>	
11	FL04	FLOOR TRIM	STAINLESS STEEL	S.S 304 GRADE T-SHAPE TRANSITION TRIM	MATTE	SDS-PROFILES /EQUIVALENT	<a href="https://sdspfiles.com/product/304-t-shape-t-profile-now-available-in-pure-dk-brand/">https://sdspfiles.com/product/304-t-shape-t-profile-now-available-in-pure-dk-brand/</a>	
<b>WALL TILES</b>								
12	WT01	WALL	CERAMIC TILE	100X100MM WHITE CERAMIC TILE WITH PINK GROUT	GLOSSY	RAK CERAMICS/EQUIVALENT	<a href="https://www.rakceramics.com/en/files/our-covers/collections/white-collection/">https://www.rakceramics.com/en/files/our-covers/collections/white-collection/</a>	
13	WT02	WALL COLUMN	CERAMIC TILE	100X100MM, GREEN SHEEN COLOUR CERAMIC TILE WITH WHITE GROUT	GLOSSY	PICC OLOMOSAIC/EQUIVALENT	<a href="https://www.piccolomosaic.in/product/143-2">https://www.piccolomosaic.in/product/143-2</a>	
14	WT03	BOX COLUMN	CERAMIC TILE	100X100MM, PINK COLOUR CERAMIC TILE WITH WHITE GROUT	GLOSSY	PICC OLOMOSAIC/EQUIVALENT	<a href="https://www.piccolomosaic.in/product/143-2">https://www.piccolomosaic.in/product/143-2</a>	
<b>GRAPHICS</b>								
15	GR01	BOX & BULKHEAD	VINYL	VINYL STICKER	NEUTRAL	LOCALLY SOURCED	NA	
<b>GLASS</b>								
16	GL01	IMPULSE UNIT(FRONT COUNTER)	NEUTRAL	8MM THK TOUGHENED GLASS	NEUTRAL	LOCALLY SOURCED	NA	
CONTRACTOR TO SUBMIT SAMPLES FOR APPROVAL								

C01 19.02.24 GOOD FOR CONSTRUCTION HOD NM  
REV DATE DESCRIPTION DRN CHK








PROJECT  
**FF-045**  
**MILIE COOKIES**  
**HYDERABAD AIRPORT**




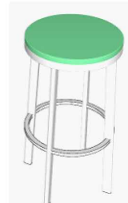
DRAWING TITLE  
**GENERAL NOTES & FINISHES SCHEDULE**

SCALE NTS DATE 19.02.2024 DRAWN HOD A3 SHEET

STATUS  
**GOOD FOR CONSTRUCTION**

ORG PROJECT NO DRAWING TYPE NUMBER REV  
**TFS XXXX 02GA 003 C01**

LIGHT & FIXTURE LEGEND					
SI.NO	CODE	DESCRIPTION	Qty	REFERENCE/BRAND	IMAGE
1	LT01	<b>PENDANT LIGHT-01</b> WABI SABI PENDANT LIGHTS BODY COLOUR:PURE WHITE LIGHT TEMP:3000K	3	<a href="https://www.crosby.co.in/product/pendant-light-impressive-lamp-with-typical-japanese-wabi-sabi-style/?v=56b5fbba0fe8">https://www.crosby.co.in/product/pendant-light-impressive-lamp-with-typical-japanese-wabi-sabi-style/?v=56b5fbba0fe8</a>	
2	LT02	<b>PENDANT LIGHT-02</b> COB PENDANT LAMP- FS3036-15 BODY COLOUR:WHITE LIGHT TEMP:3000K	3	<a href="https://www.est.net.in/indoor-led-lighting/led-pendant-lights/pendant-light-fs3036-15/">https://www.est.net.in/indoor-led-lighting/led-pendant-lights/pendant-light-fs3036-15/</a>	
3	LT03	<b>RECESSED DOWN LIGHT</b> CORE LINE SLIM DOWN LIGHT DIA:205MM W ALLTAGE:22.5W LIGHT TEMP:3000K	7	<a href="https://www.lighting.philips.com/prof/indoor-luminaires/downlights/coreline-slimdownlight/910505101197_EU/product">https://www.lighting.philips.com/prof/indoor-luminaires/downlights/coreline-slimdownlight/910505101197_EU/product</a>	
4	LT04	<b>LED STRIP LIGHT WITH DIFFUSER</b> LIGHT TEMP:3000K	AS PER DWG	<a href="https://havells.com/en/consumer/lighting/led%20strips/flexion-strip-light/flexion-led-strip-24-w-rgb.html">https://havells.com/en/consumer/lighting/led%20strips/flexion-strip-light/flexion-led-strip-24-w-rgb.html</a>	
5	DD	<b>40" DIGITAL DISPLAY(VERTICAL ORIENTATION)</b> FULL HD 1080P SMART LED TV - 40" CLASS (39.5" DIAG)/EQUIVALENT	3	<a href="https://www.lg.com/us/tvs/lg-40LF6300-smart-led-tv">https://www.lg.com/us/tvs/lg-40LF6300-smart-led-tv</a>	

FURNITURE LEGEND					
SL.NO	CODE	DESCRIPTION	QTY	REFERENCE/BRAND	IMAGE
1	HC1	<b>HIGH CHAIR-01</b> ROUND BAR STOOL FINISHED IN WHITE COLOUR METAL FRAME AND PEARL VIOLET COLOUR LEATHERETTE CUSHION STOOL DIA:450MM SEAT HEIGHT:770MM	2	SOURCE LOCALLY	
2	HC2	<b>HIGH CHAIR-02</b> ROUND BAR STOOL FINISHED IN WHITE COLOUR METAL FRAME AND LIGHT BLUE COLOUR LEATHERETTE CUSHION STOOL DIA:450MM SEAT HEIGHT:770MM	2	SOURCE LOCALLY	
3	HC3	<b>HIGH CHAIR-03</b> ROUND BAR STOOL FINISHED IN WHITE COLOUR METAL FRAME AND PINK COLOUR LEATHERETTE CUSHION STOOL DIA:450MM SEAT HEIGHT:770MM	2	SOURCE LOCALLY	
4	HC4	<b>HIGH CHAIR-04</b> ROUND BAR STOOL FINISHED IN WHITE COLOUR METAL FRAME AND LIGHT GREEN COLOUR LEATHERETTE CUSHION STOOL DIA:450MM SEAT HEIGHT:770MM	2	SOURCE LOCALLY	

C01 19.02.24 GOOD FOR CONSTRUCTION HOD NM  
REV DATE DESCRIPTION DRN CHK




PROJECT  
FF-045  
MILIE COOKIES  
HYDERABAD AIRPORT

DRAWING TITLE  
FURNITURE,LIGHT & FIXTURE  
LEGEND

SCALE NTS DATE 19.02.2024 DRAWN HOD A3 SHEET

STATUS  
GOOD FOR CONSTRUCTION

ORG PROJECT NO DRAWING TYPE NUMBER REV  
TFS XXXX 02GA 004 C01

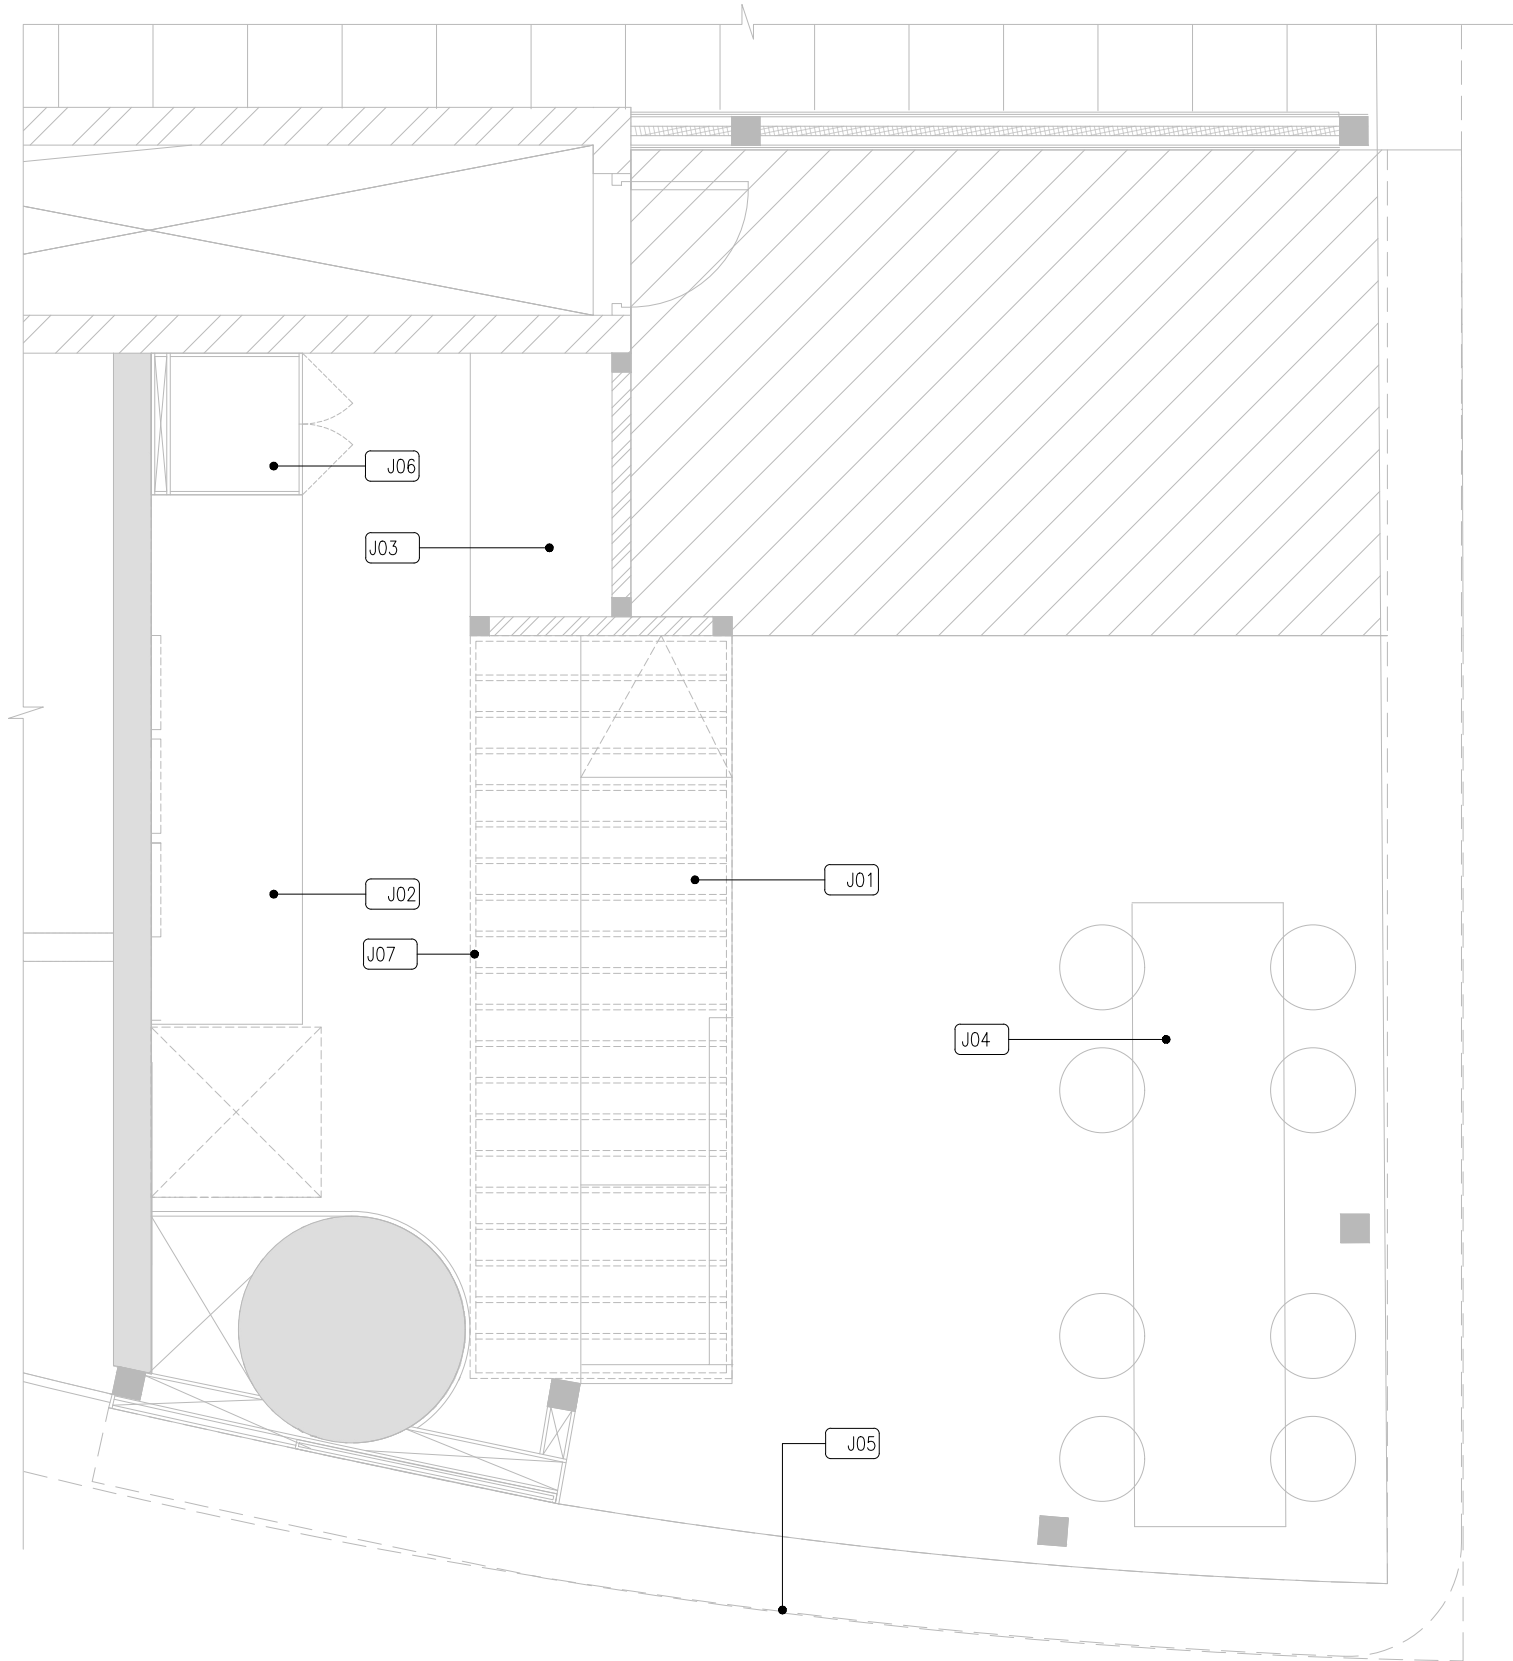

DETAIL DRAWING LEGEND		
CODE	DESCRIPTION	ADDITIONAL INFORMATION
J01	FRONT COUNTER	REFER: 04DE-400 TO 04DE-401
J02	REAR COUNTER -01	REFER: 04DE-402
J03	REAR COUNTER -02	REFER: 04DE-403
J04	COMMUNITY TABLE	REFER: 04DE-404
J05	BULKHEAD	REFER: 04DE-405 TO 004DE-406
J06	SERVICE CLOSET	REFER: 04DE-407
J07	BAFFLE CEILING	REFER: 04DE-408
J08	SIGNAGE	REFER: 04DE-409

01 DETAIL DRAWING LEGEND  
02GA-005 1:40

REV	DATE	DESCRIPTION	HOD	NM
C01	19.02.24	GOOD FOR CONSTRUCTION		



PROJECT  
FF-045  
MILIE COOKIES  
HYDERABAD AIRPORT


DRAWING TITLE  
DETAIL DRAWING LEGEND

SCALE 1:40 DATE 19.02.2024 DRAWN HOD A3 SHEET

STATUS  
GOOD FOR CONSTRUCTION

ORG	PROJECT NO	DRAWING TYPE	NUMBER	REV
TFS	XXXX	02GA	005	C01

INDICATES UNIT DEMISE  
INDICATES LOCATION OF PROPOSED SIGNAGE

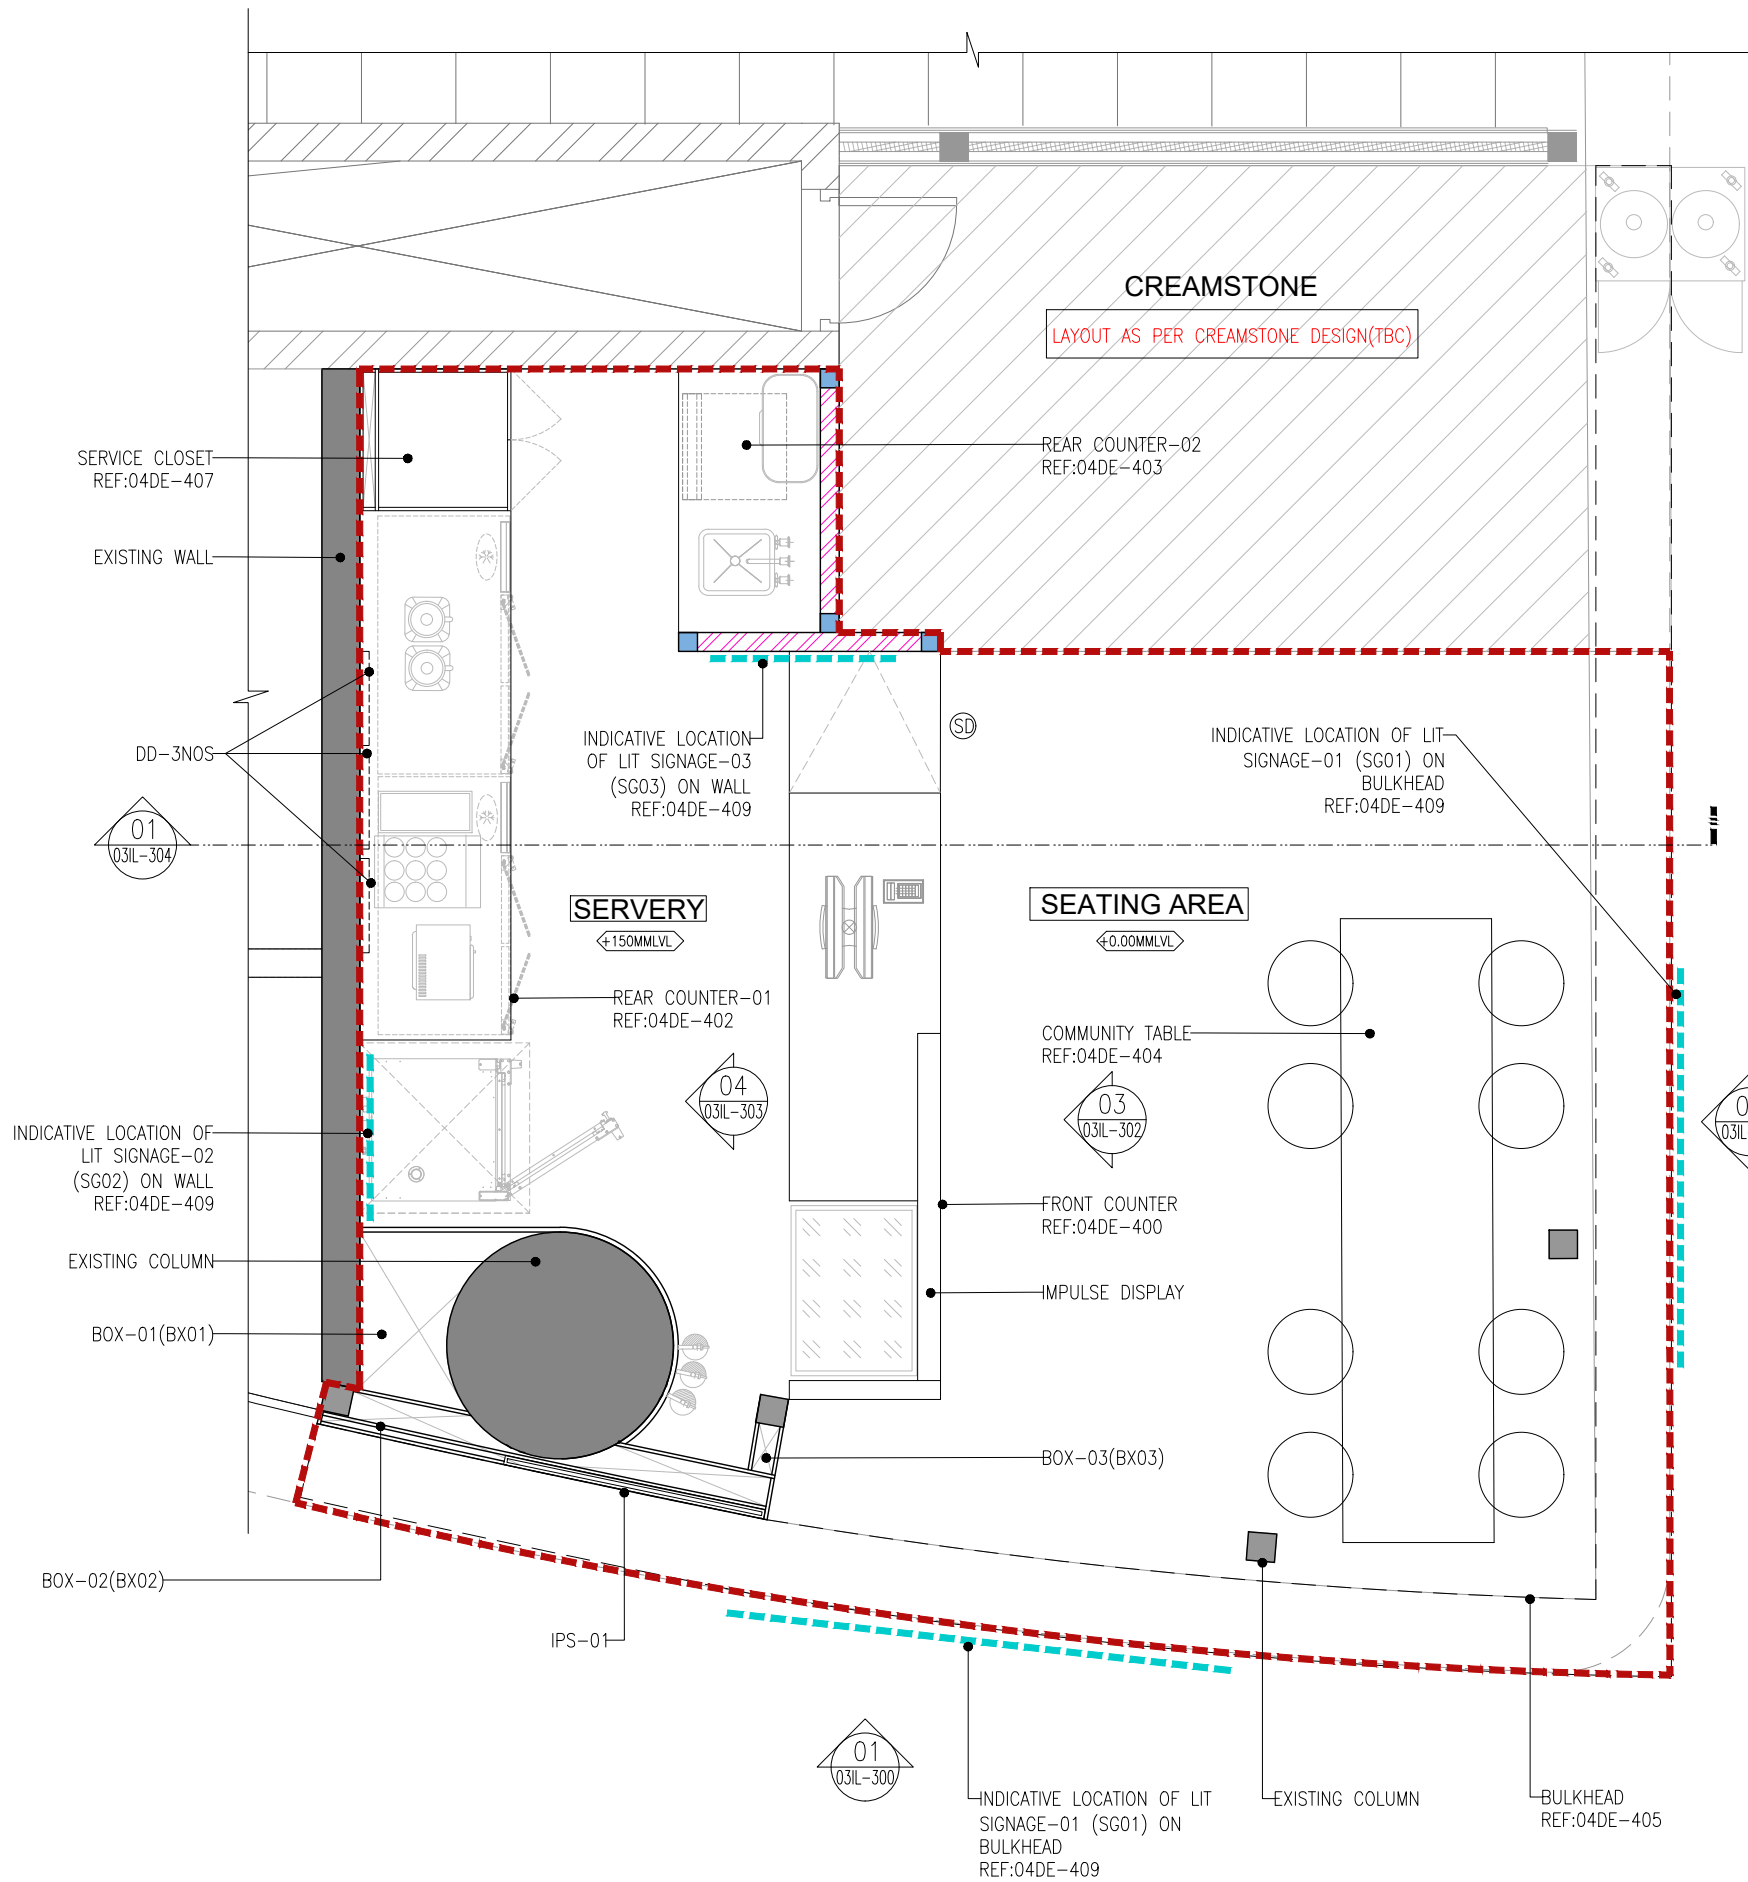

PATTERN	TYPE	HEIGHT
	PROPOSED 100MM THK LOW HEIGHT MASONRY WALL	+3000 MM
	EXISTING WALL / COLUMN	-
	PROPOSED 100X100MM CONCRETE FRAMING (M.20 MIX WITH NOMINAL REINFORCEMENTS)	+3000 MM

CODE	NAME	SIZE(MM)	HEIGHT
BX01	BOX-01	AS PER DWG	+3000MM
BX02	BOX-02	AS PER DWG	+3000MM
BX03	BOX-03	260X145MM	+3000MM

#	DESCRIPTION	AREA/M <sup>2</sup>
1	SERVERY	15.85
2	SEATING	17.03
TOTAL		51.17

CODE	SIZE	COUNT	TYPE	SWING	LOCK	FIRE RATING
SD	750X775	1	SWING DOOR	SINGLE	NO	1HR

CODE	SIZE	NAME	NOS.
IPS	1425X2940MM	IPS PANEL	1

CODE	SIZE	NAME	NOS.
DD	40"	DIGITAL DISPLAY (VERTICAL ORIENTATION)	3

#	DESCRIPTION	NOS
1	COMMUNITY SEATING	08
TOTAL		08

C01 19.02.24 GOOD FOR CONSTRUCTION HOD NM  
REV DATE DESCRIPTION DRN CHK



PROJECT  
**FF-045**  
**MILIE COOKIES**  
**HYDERABAD AIRPORT**


DRAWING TITLE  
**GENERAL ARRANGEMENT PLAN**

**01** GENERAL ARRANGEMENT PLAN  
02GA-100 1:40

SCALE 1:40 DATE 19.02.2024 DRAWN HOD A3 SHEET

STATUS  
**GOOD FOR CONSTRUCTION**

ORG PROJECT NO DRAWING TYPE NUMBER REV  
**TFS XXXX 02GA 100 C01**

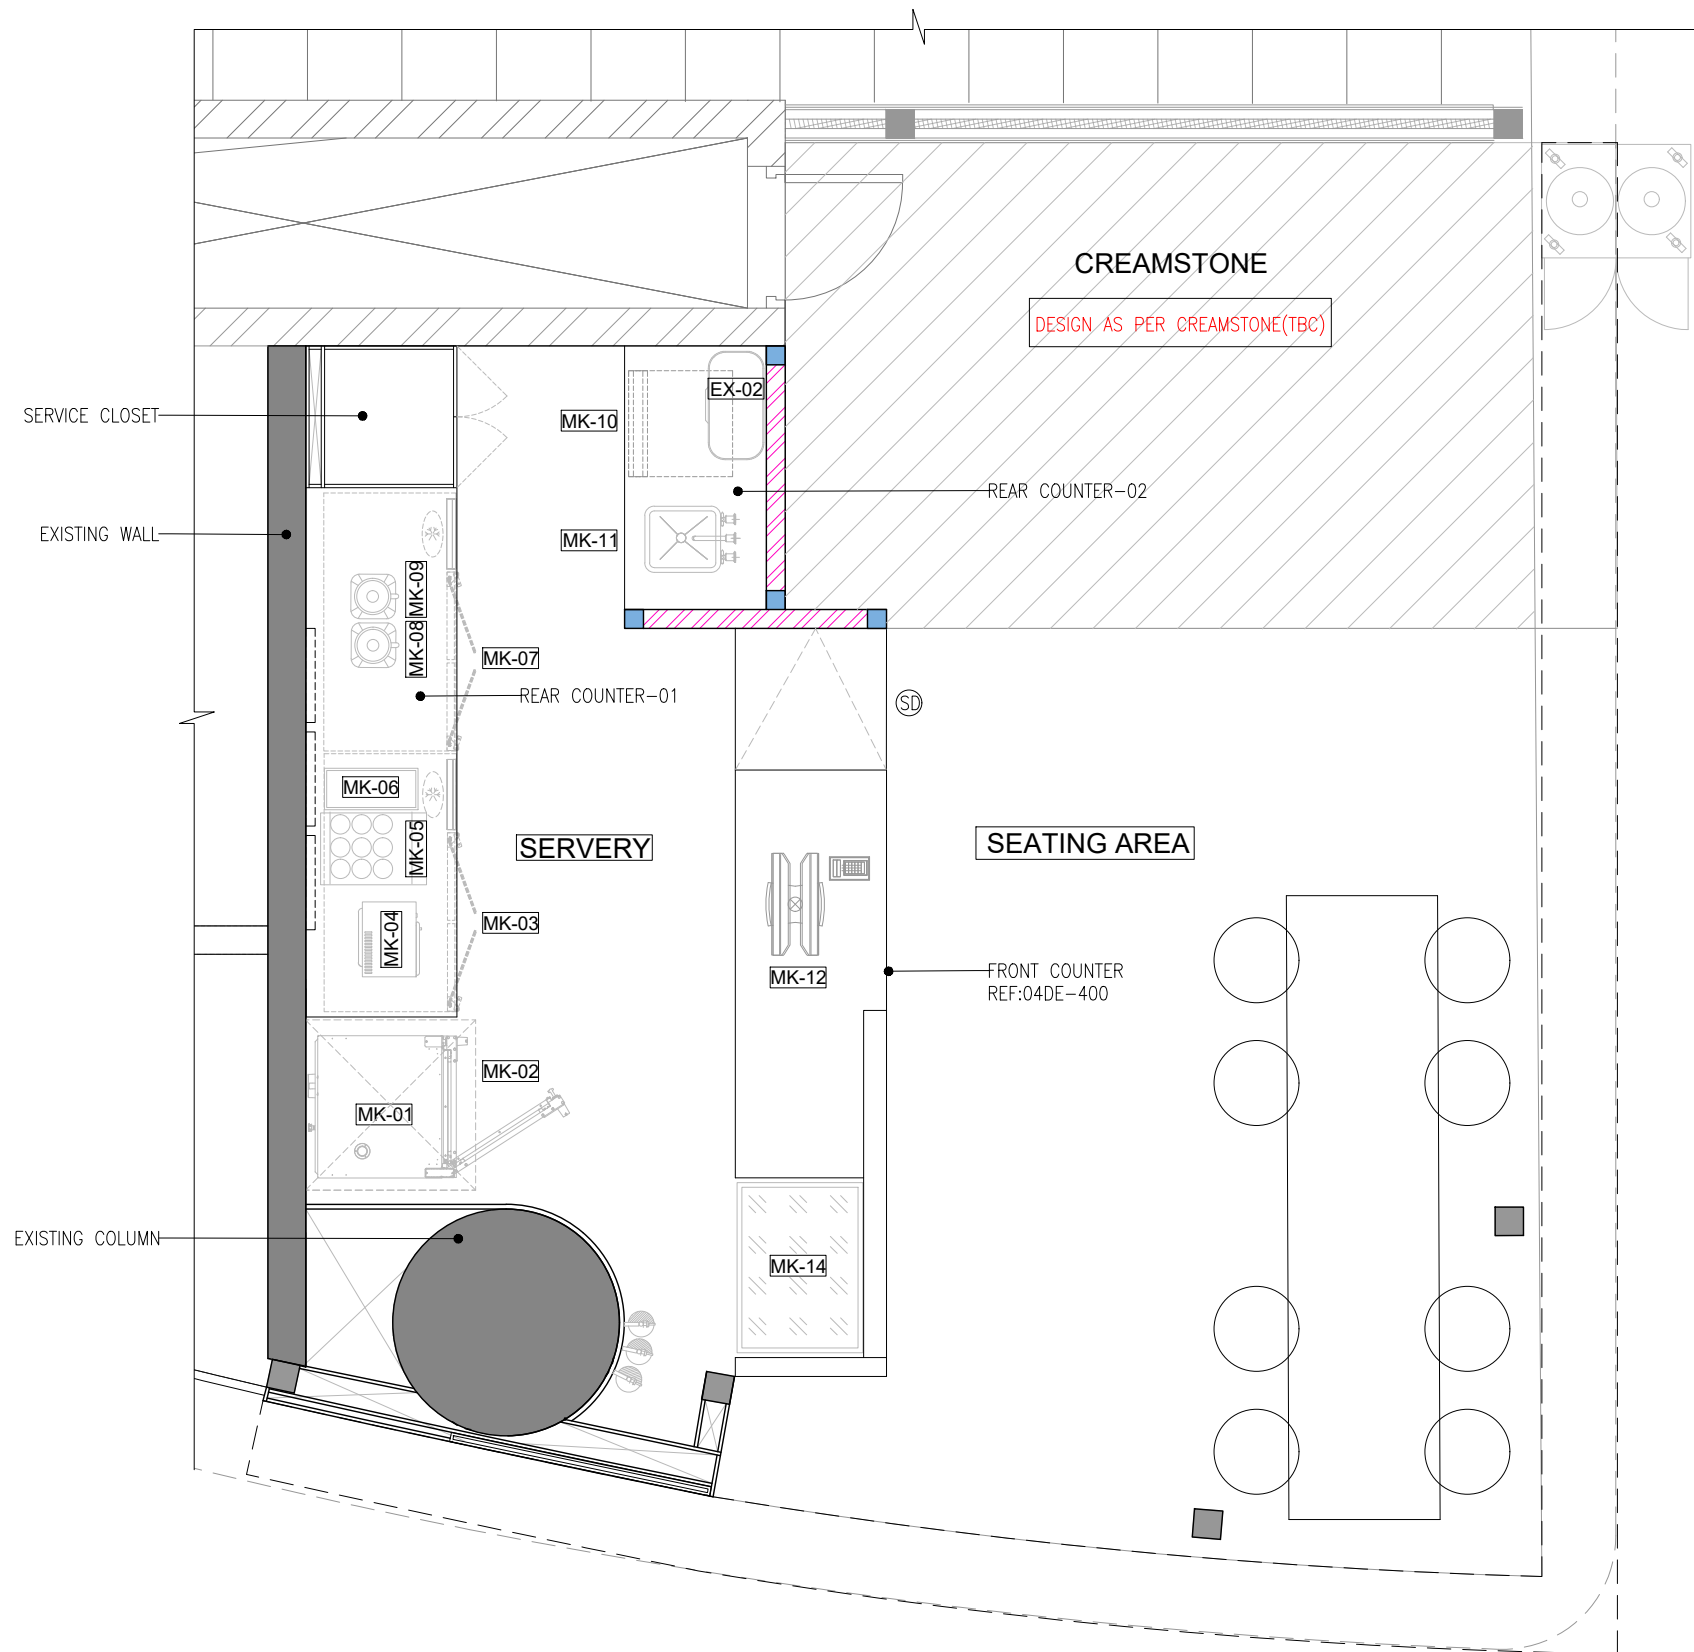

EQUIPMENT SHEDULE			
CODE	DESCRIPTION	DIMENSION (All Dimensions in MM)(L x W x H)	COUNT
MK - 01	COMBI OVEN	750 x783 x 675	1
MK - 02	TABLE FOR KEEPING COMBI - OVEN WITH ARRANGEMENTS FOR KEEPING TRAYS	900 x 850 x 850	1
MK - 03	TWO DOOR WORK TOP CHILLER ( COMPRESSOR ON RHS )	1365 x 700 x 850	1
MK - 04	MICROWAVE OVEN	511 x 311 x 432	1
MK - 05	COFFEE MACHINE	380 x 560 x 690	1
MK - 06	MILK FRIDGE	228 x 469 x 344	1
MK - 07	TWO DOOR WORK TOP CHILLER ( COMPRESSOR ON RHS )	1365 x 700 x 850	1
MK - 08	BLENDER	240 x 250 x 460	1
MK - 09	BLENDER	240 x 250 x 460	1
MK - 10	UNDER COUNTER ICE CUBE MACHINE	550 x 550 x 800	1
MK - 11	COUNTER MODEL SINK	500 x 432 x 210 Deep	1
MK - 12	POS WITH PRINTER		1
MK - 14	COLD DISPLAY COUNTER	900 x 665 x 1235	2
EXT - 02	WATER BOILER (GEYSER)	15 Lits. Capacity	1

01 EQUIPMENT LAYOUT  
02GA-101 1:40

C01 19.02.24 GOOD FOR CONSTRUCTION HOD NM  
REV DATE DESCRIPTION DRN CHK



PROJECT  
FF-045  
MILIE COOKIES  
HYDERABAD AIRPORT


DRAWING TITLE  
EQUIPMENT LAYOUT

SCALE 1:40 DATE 19.02.2024 DRAWN HOD A3 SHEET


STATUS  
GOOD FOR CONSTRUCTION

ORG PROJECT NO DRAWING TYPE NUMBER REV  
TFS XXXX 02GA 101 C01

WALL CONSTRUCTION DETAILS  
MENTIONED ARE INDICATIVE ONLY.  
CONTRACTOR TO FOLLOW TYPICAL  
BLOCK WALL CONSTRUCTION DETAILS  
BY AIRPORT

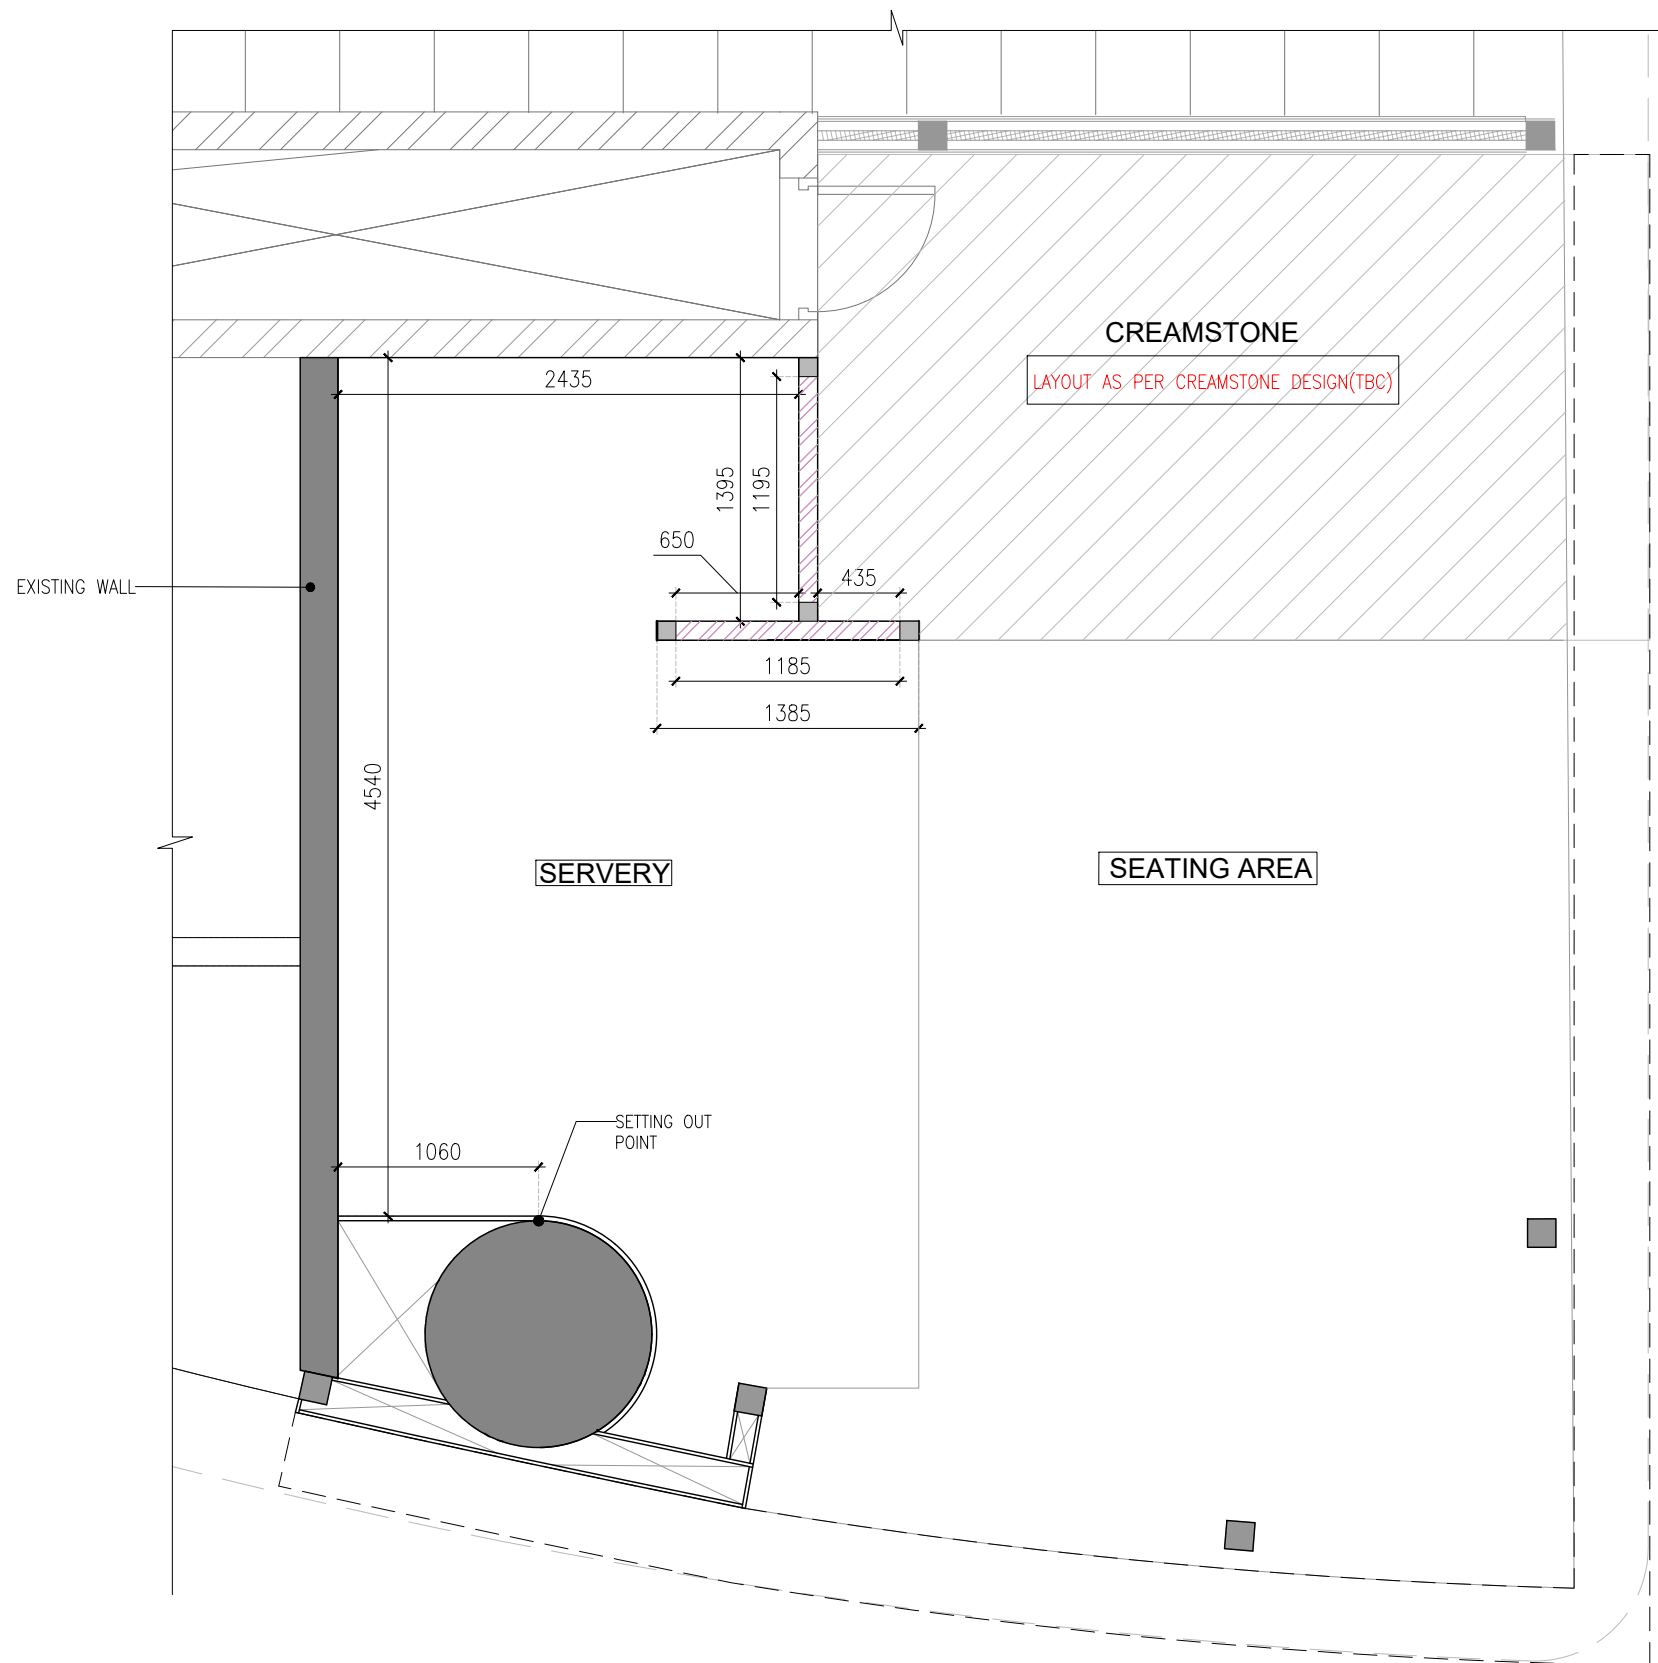

WALL LEGEND		
PATTERN	TYPE	HEIGHT
	PROPOSED 100MM THK LOW HEIGHT MASONRY WALL	+3000 MM
	EXISTING WALL / COLUMN	-
	PROPOSED 100X100MM CONCRETE FRAMING (M.20 MIX WITH NOMINAL REINFORCEMENTS)	+3000 MM

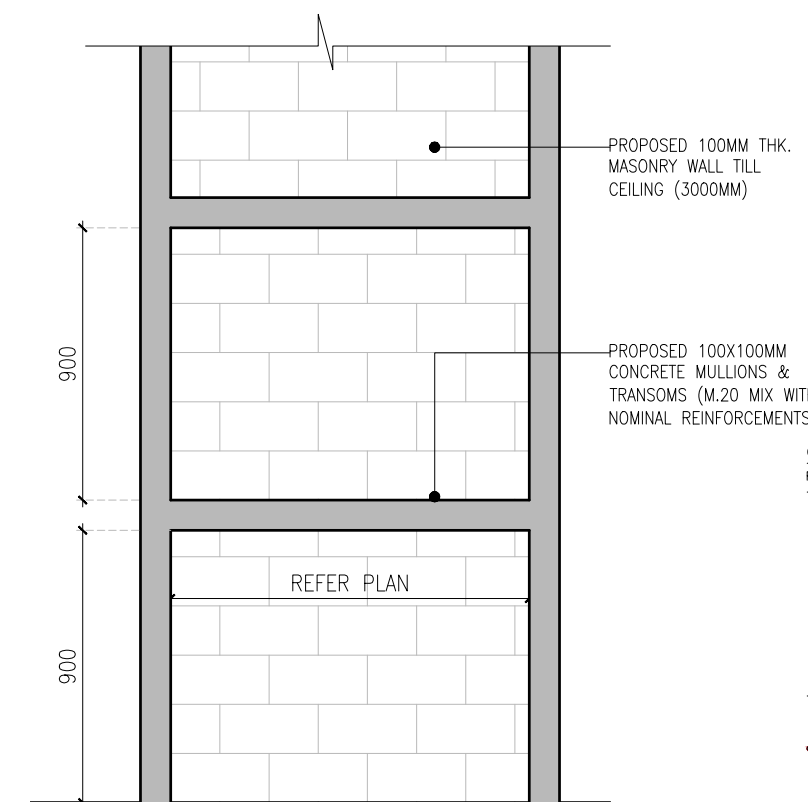

TYPICAL STRUCTURAL ELEVATION  
(WALL CONSTRUCTION) SCALE 1:25

REV	DATE	DESCRIPTION	HOD	NM
C01	19.02.24	GOOD FOR CONSTRUCTION		



PROJECT  
FF-045  
MILIE COOKIES  
HYDERABAD AIRPORT

DRAWING TITLE  
SETTING OUT PLAN


SCALE 1:40 DATE 19.02.2024 DRAWN HOD A3 SHEET

STATUS  
GOOD FOR CONSTRUCTION

ORG	PROJECT NO	DRAWING TYPE	NUMBER	REV
TFS	XXXX	02GA	102	C01

01 WALL DETAIL LAYOUT  
02GA-102 1:40



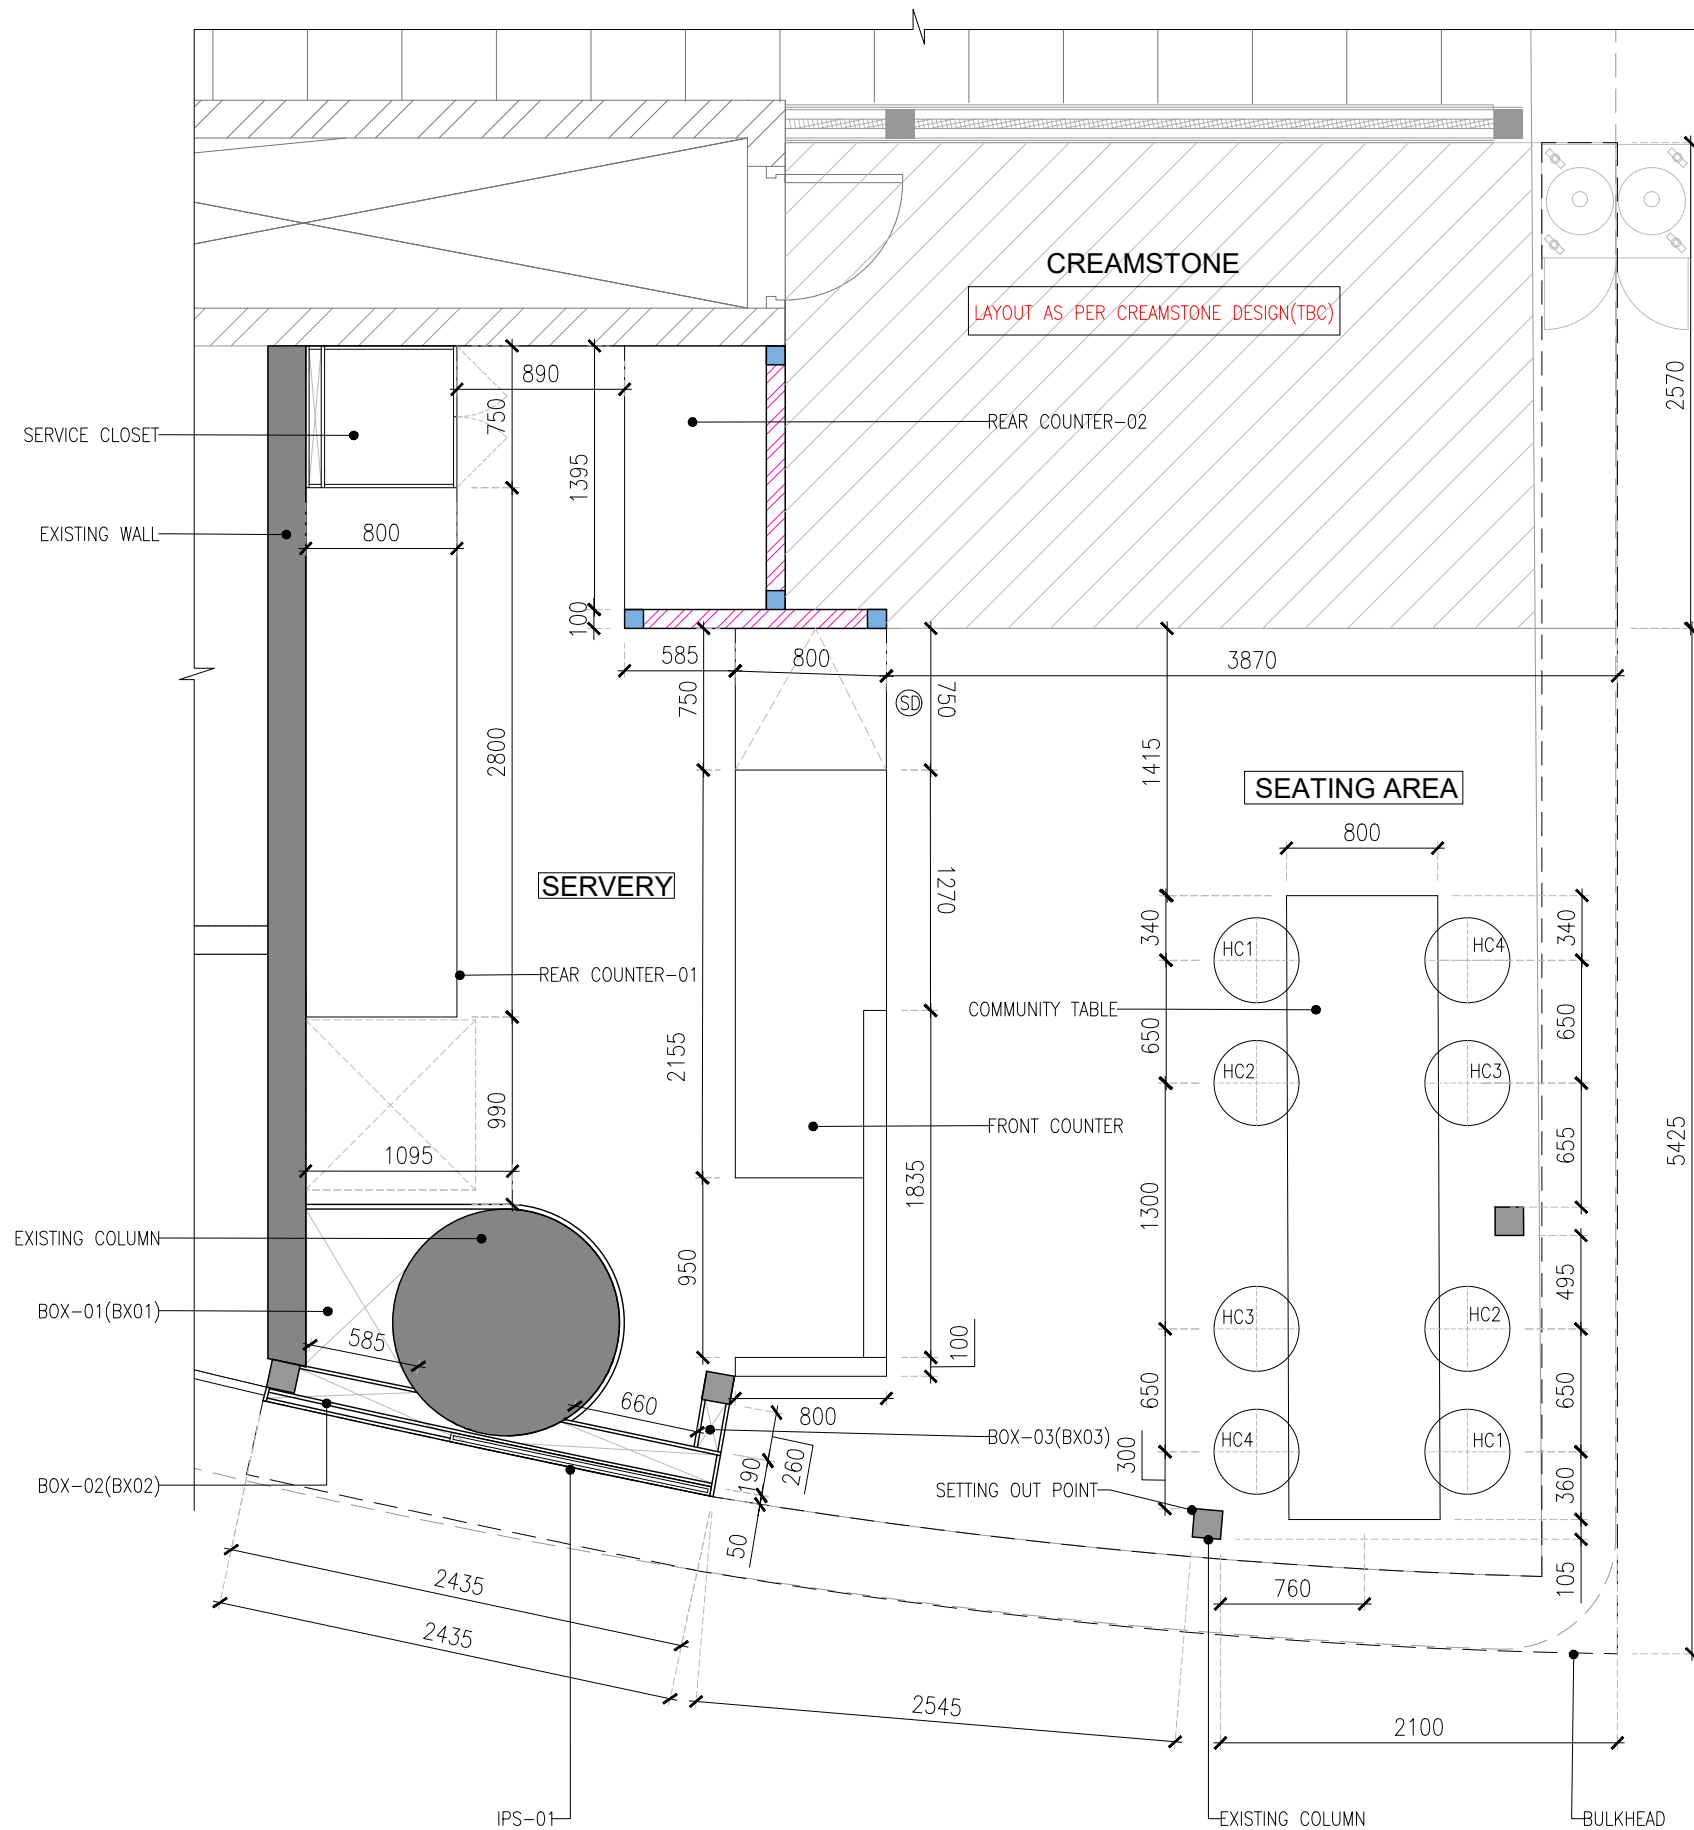

WALL LEGEND		
PATTERN	TYPE	HEIGHT
	PROPOSED 100MM THK LOW HEIGHT MASONRY WALL	+3000 MM
	EXISTING WALL / COLUMN	-
	PROPOSED 100X100MM CONCRETE FRAMING (M.20 MIX WITH NOMINAL REINFORCEMENTS)	+3000 MM

BOX LEGEND			
CODE	NAME	SIZE(MM)	HEIGHT
BX01	BOX-01	AS PER DWG	+3000MM
BX02	BOX-02	AS PER DWG	+3000MM
BX03	BOX-03	260X145MM	+3000MM

FURNITURE LEGEND		
CODE	DESCRIPTION	COUNT
HC1	HIGH CHAIR-01	02
HC2	HIGH CHAIR-02	02
HC3	HIGH CHAIR-03	02
HC4	HIGH CHAIR-04	02
TOTAL		08

C01 19.02.24 GOOD FOR CONSTRUCTION HOD NM  
REV DATE DESCRIPTION DRN CHK



PROJECT  
FF-045  
MILIE COOKIES  
HYDERABAD AIRPORT


DRAWING TITLE  
SETTING OUT PLAN

SCALE 1:40 DATE 19.02.2024 DRAWN HOD A3 SHEET

STATUS  
GOOD FOR CONSTRUCTION

ORG PROJECT NO DRAWING TYPE NUMBER REV  
TFS XXXX 02GA 103 C01

01 SETTING OUT PLAN  
02GA-103 1:40

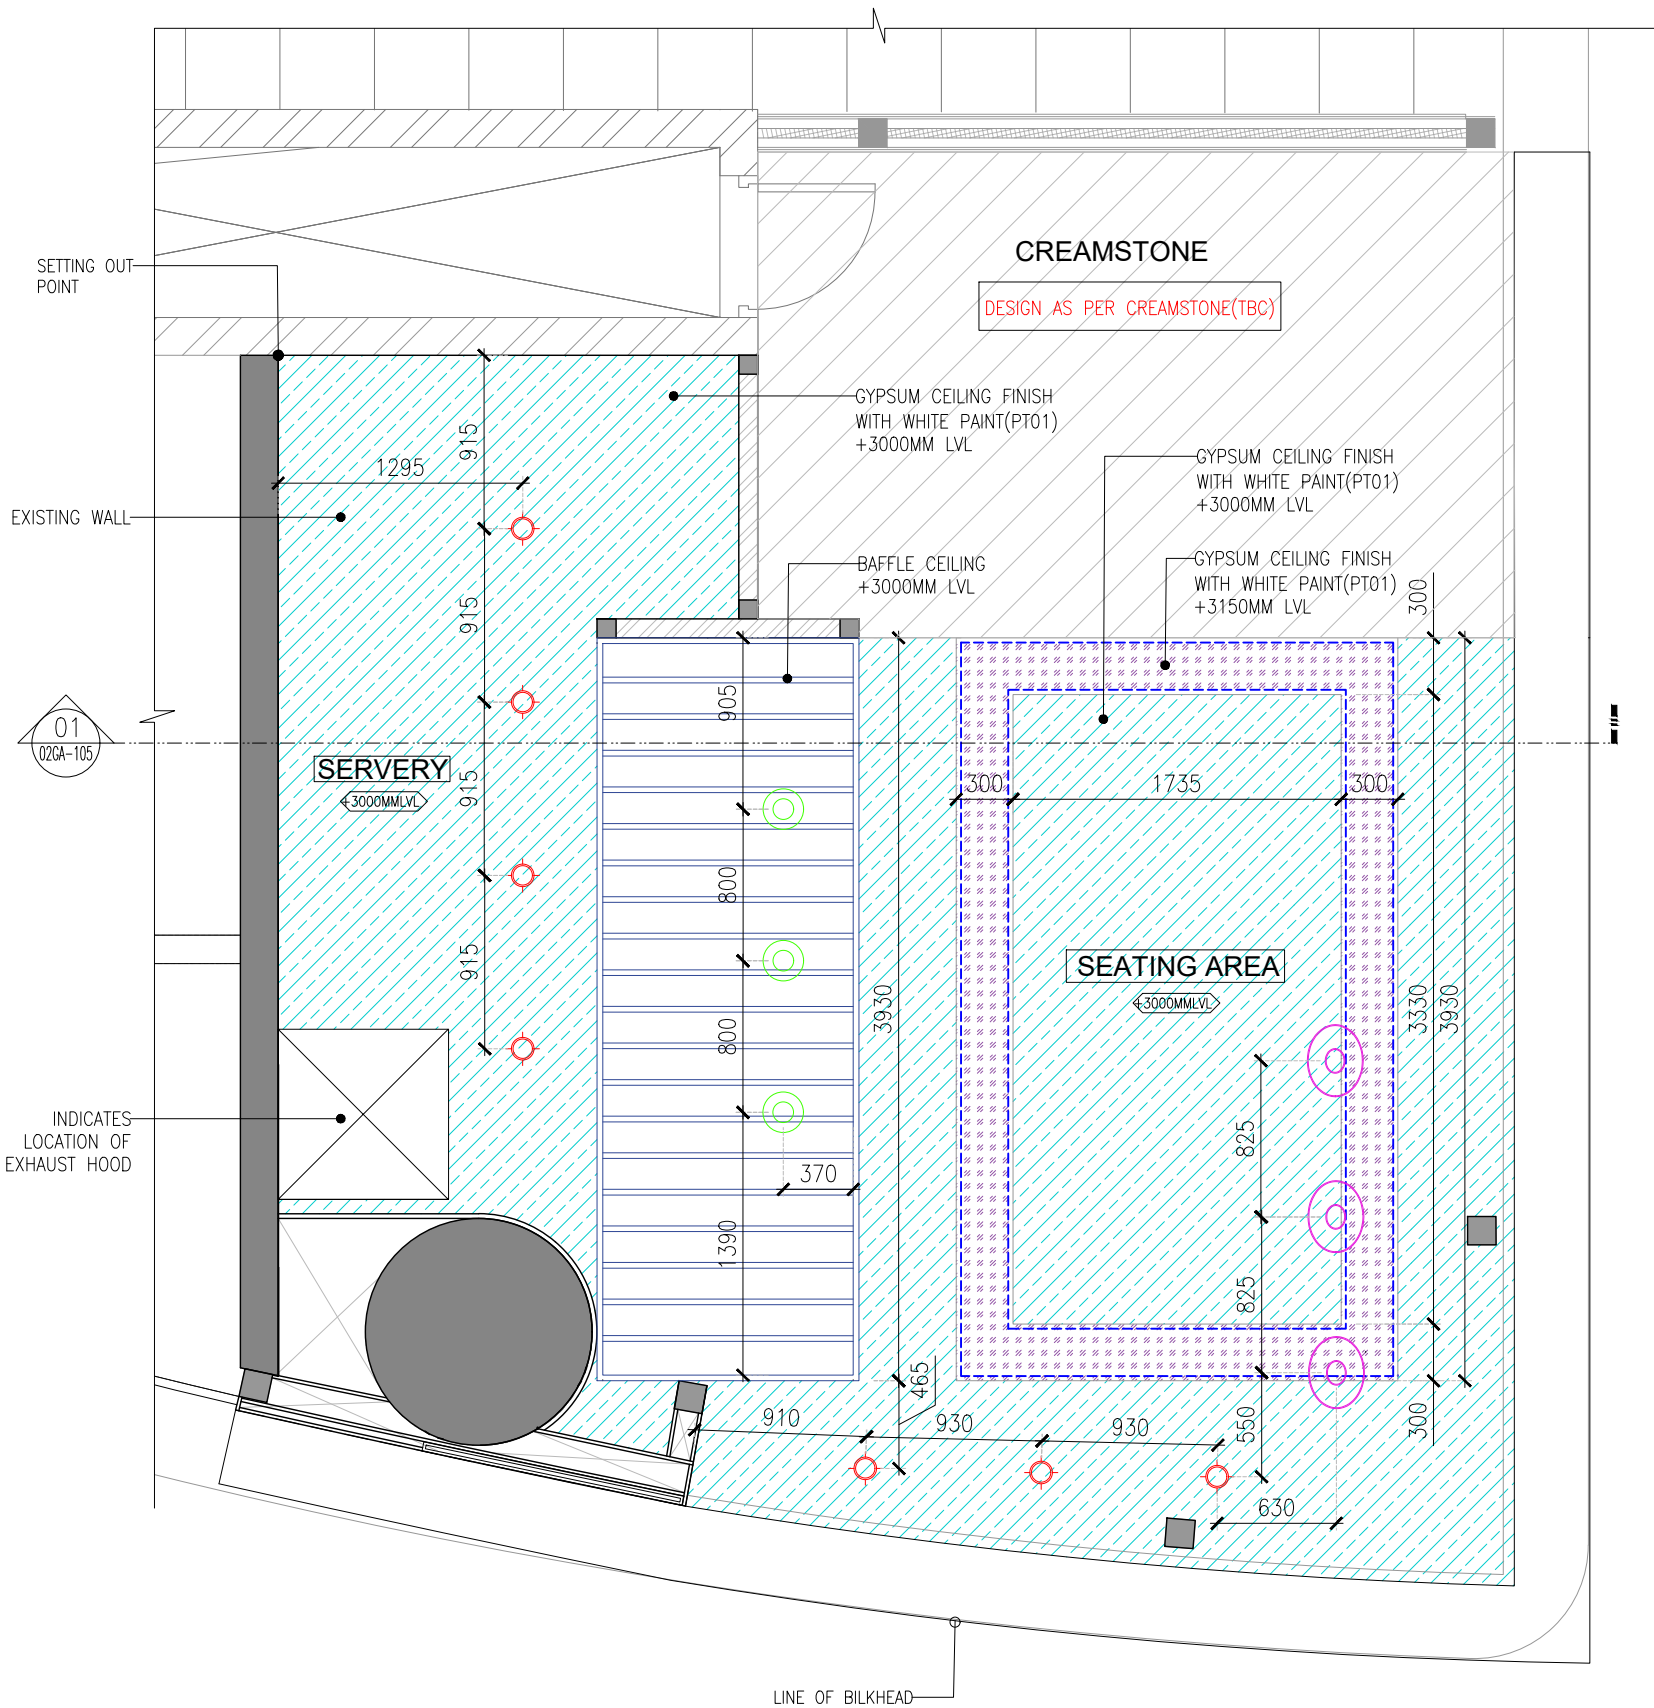

LIGHT FIXTURE LEGEND				
SYMBOL	TYPE	CODE	NOS.	IMAGE
	PENDANT LIGHT-01	LT01	03	
	PENDANT LIGHT-02	LT02	03	
	SPOT LIGHT	LT03	07	
	LED STRIP LIGHT WITH DIFFUSER	LT04	22.65Mtr	

CEILING LEGEND			
PATTERN	TYPE	BOTTOM OF CEILING IN MM	AREA(M <sup>2</sup> )
	GYPSUM CEILING	+3000MM	22.36
	GYPSUM CEILING	+3150MM	3.4
	BAFFLE CEILING	+3000MM	-

C01 19.02.24 GOOD FOR CONSTRUCTION HOD NM  
REV DATE DESCRIPTION DRN CHK



PROJECT  
FF-045  
MILIE COOKIES  
HYDERABAD AIRPORT


DRAWING TITLE  
RCP+LIGHTING LAYOUT-PART: A

SCALE 1:40 DATE 19.02.2024 DRAWN HOD A3 SHEET

STATUS  
GOOD FOR CONSTRUCTION

ORG PROJECT NO DRAWING TYPE NUMBER REV  
TFS XXXX 02GA 104 C01

01 RCP + LIGHTING LAYOUT :PART-A  
02GA-104/ 1:40

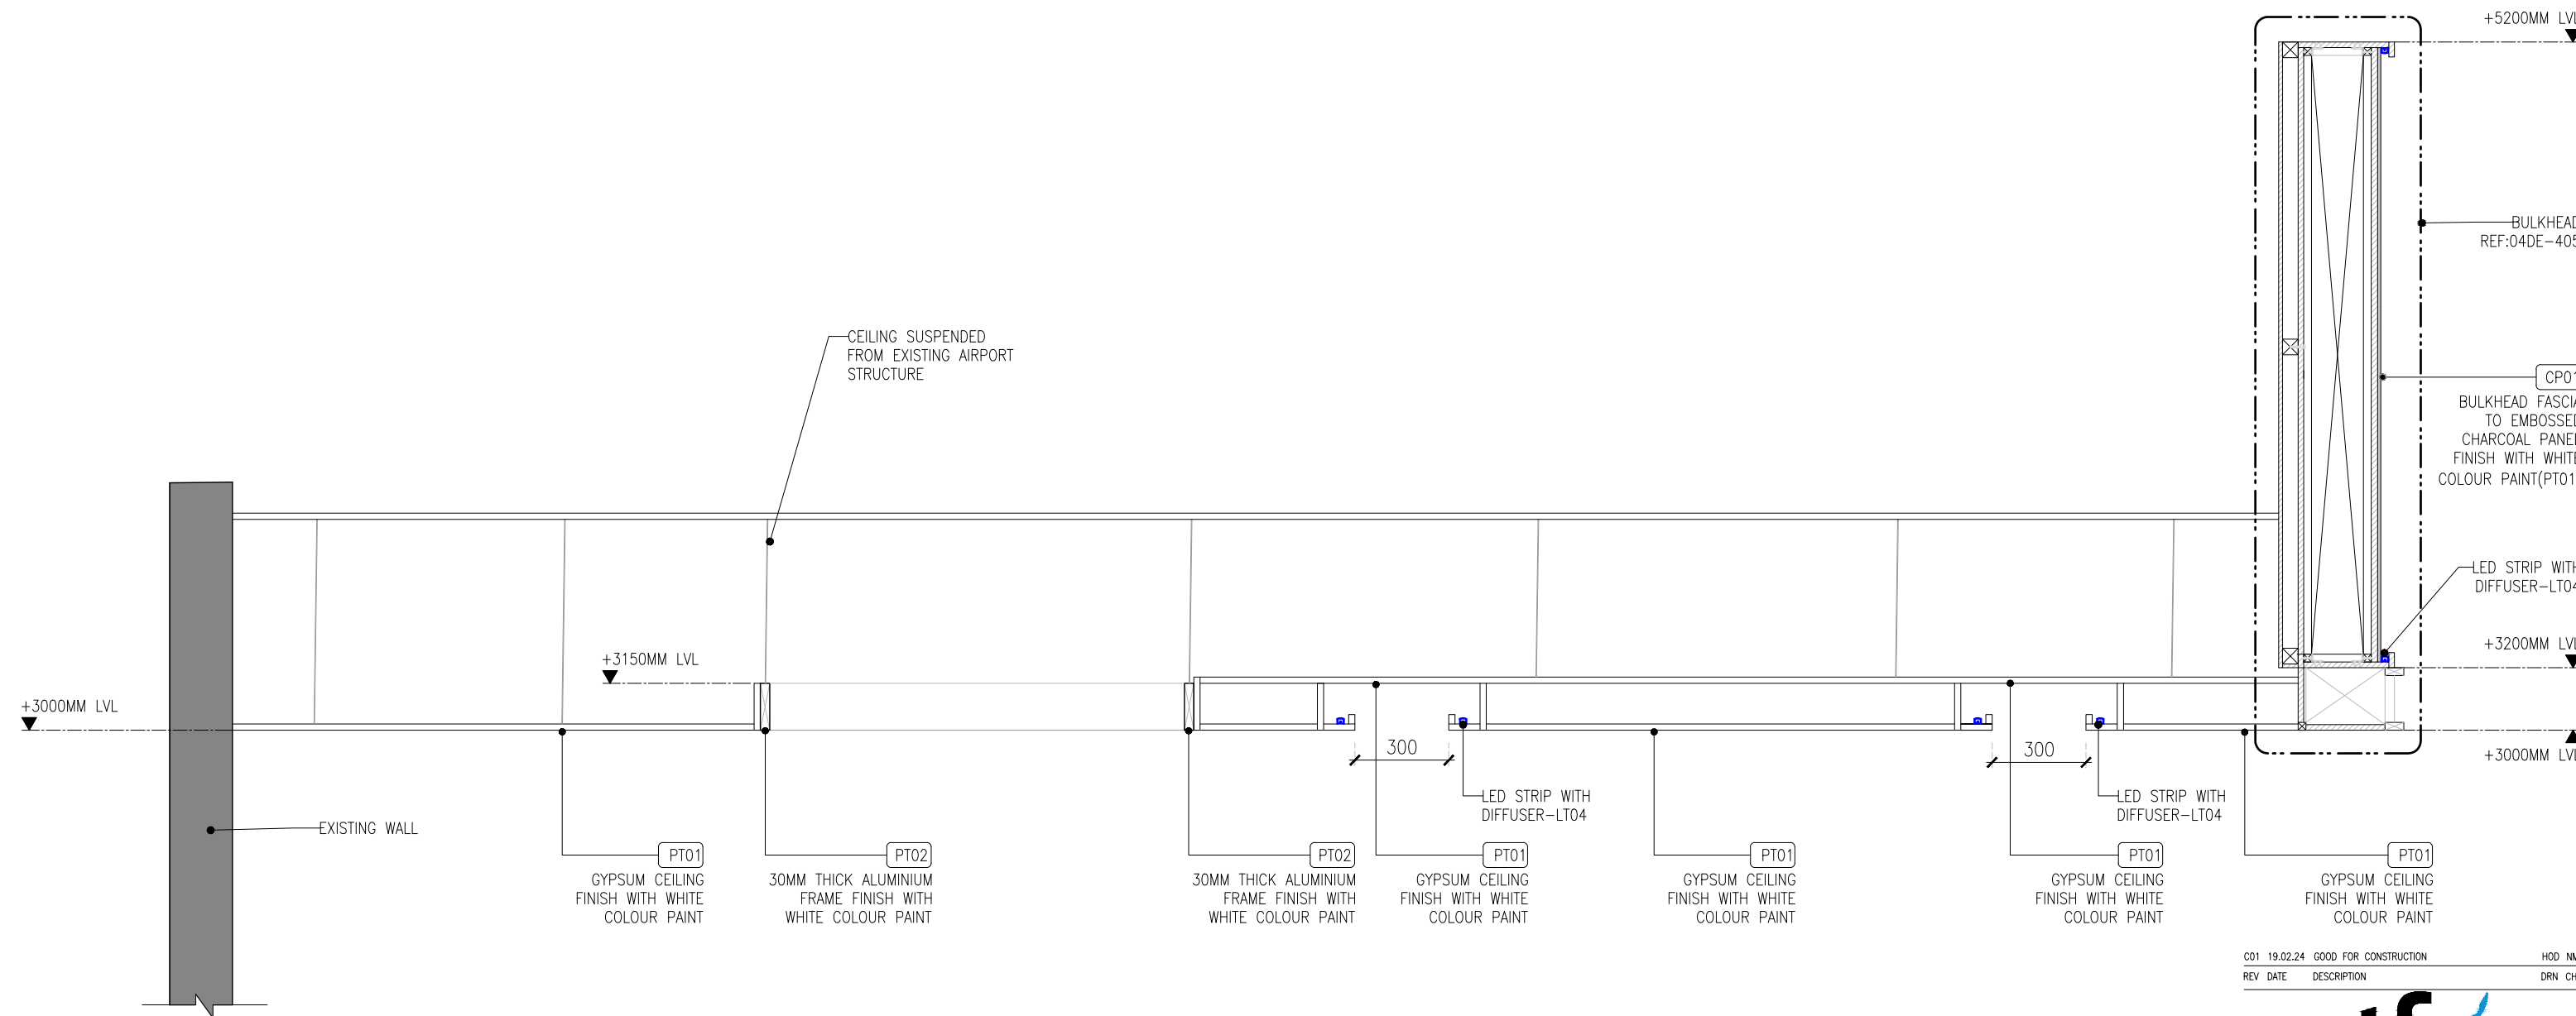

**01 SECTION-01**  
02GA-105 1:20

REV	DATE	DESCRIPTION	HOD	NM	DRN	CHK
C01	19.02.24	GOOD FOR CONSTRUCTION				




PROJECT  
**FF-045**  
**MILIE COOKIES**  
**HYDERABAD AIRPORT**

DRAWING TITLE  
**RCP+LIGHTING LAYOUT- PART:B**

SCALE 1:20 DATE 19.02.2024 DRAWN HOD A3 SHEET



STATUS  
**GOOD FOR CONSTRUCTION**

ORG	PROJECT NO	DRAWING TYPE	NUMBER	REV
TFS	XXXX	02GA	105	C01

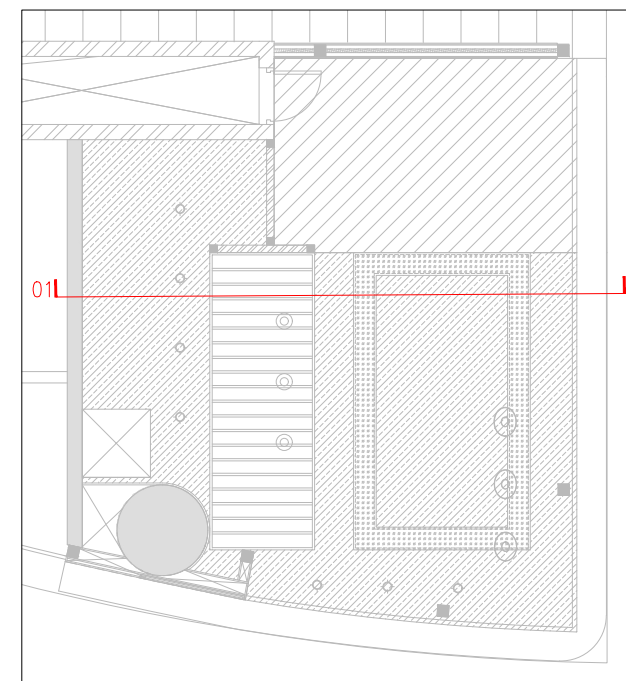


**KEY PLAN**



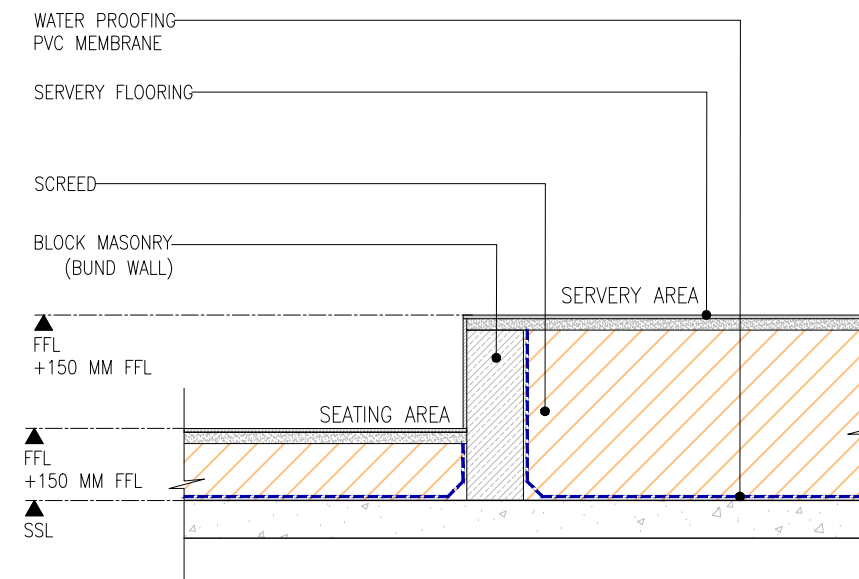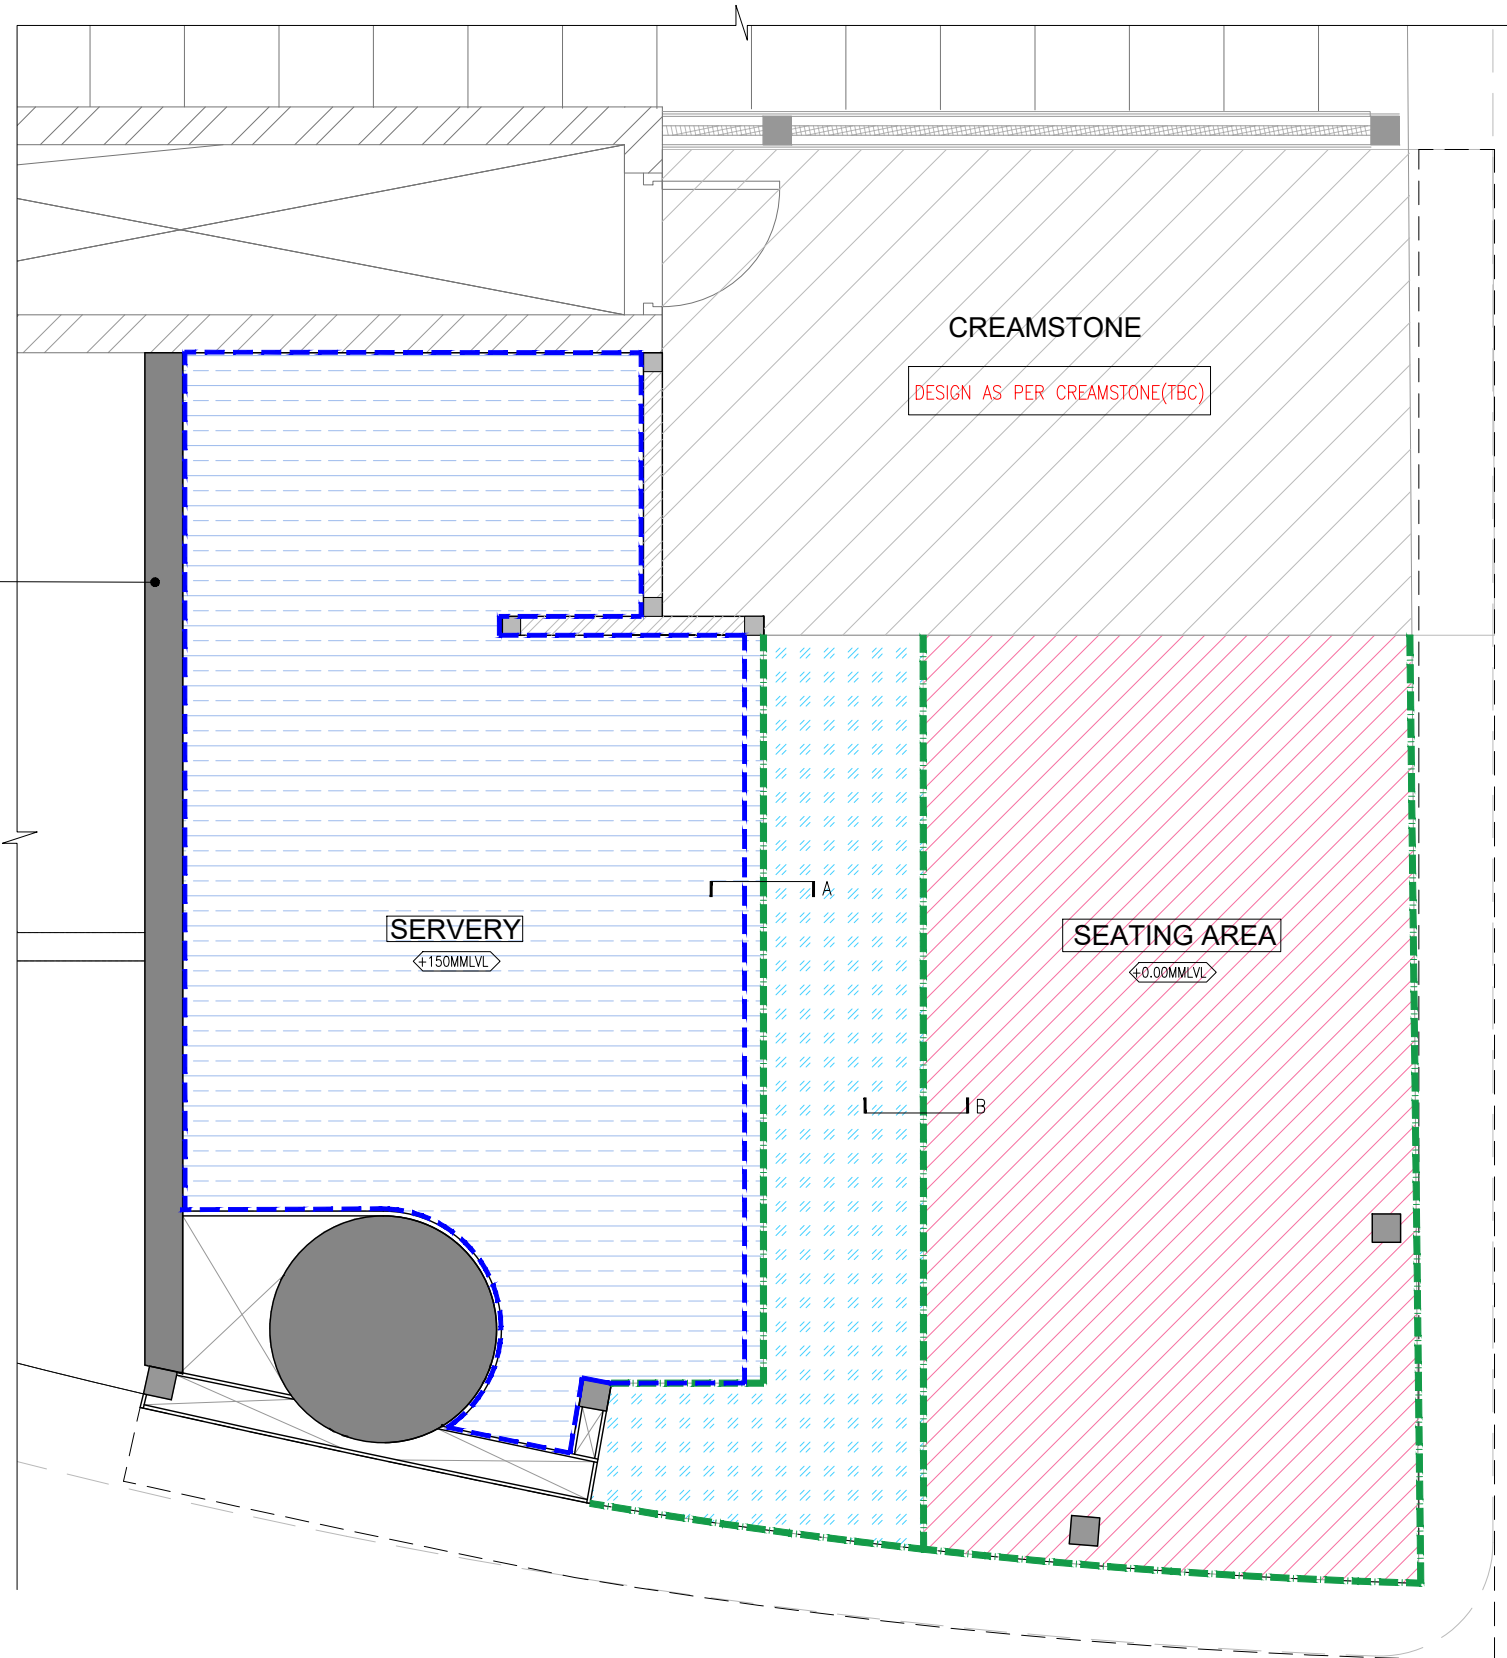

 INDICATES RAISED FLOOR DEMISE

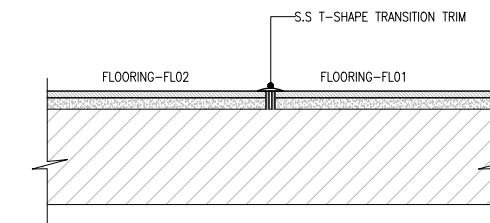

SECTION-A (SCALE 1:10)



TYPICAL FLOOR TRANSITION DETAIL SECTION-B

FLOORING LEGEND			
CODE	PATTERN	TYPE	AREA/LENGTH
FL01		POLISHED CONCRETE	12.86 M <sup>2</sup>
FL02		300X300MM PATTERNED PORCELAIN TILE	4.66 M <sup>2</sup>
FL03		600X600MM GREY COLOUR KOTA STONE	14.45M <sup>2</sup>
FL04		S.S 304 GRADE T-SHAPE TRANSITION TRIM	19.01M

REV	DATE	DESCRIPTION	HOD	NM
C01	19.02.24	GOOD FOR CONSTRUCTION		
			DRN	CHK



PROJECT  
FF-045  
MILIE COOKIES  
HYDERABAD AIRPORT

DRAWING TITLE  
FLOORING LAYOUT

SCALE AS MENTIONED DATE 19.02.2024 DRAWN HOD A3 SHEET

STATUS  
GOOD FOR CONSTRUCTION



ORG	PROJECT NO	DRAWING TYPE	NUMBER	REV
TFS	XXXX	02GA	106	C01

**01 FLOORING LAYOUT**  
02GA-106 1:40

 INDICATES RAISED FLOOR DEMISE

 WATER PROOFING AREA

TOTAL AREA TO BE WATER PROOFED= 27.3 M2

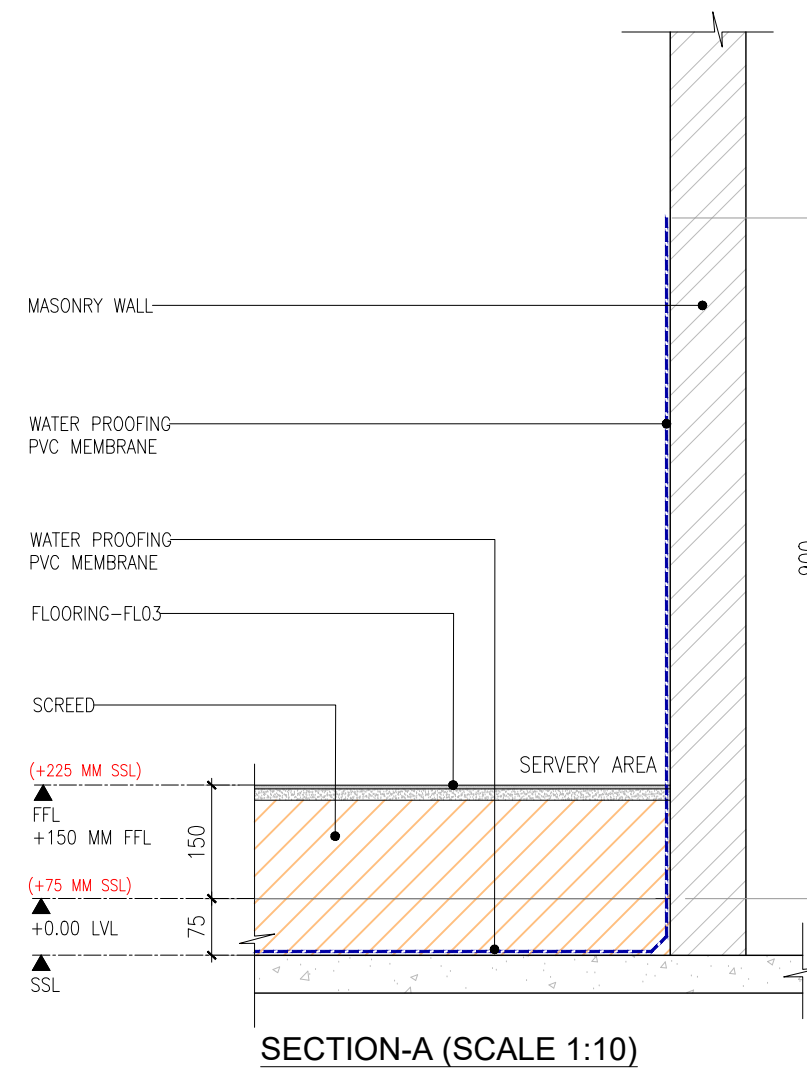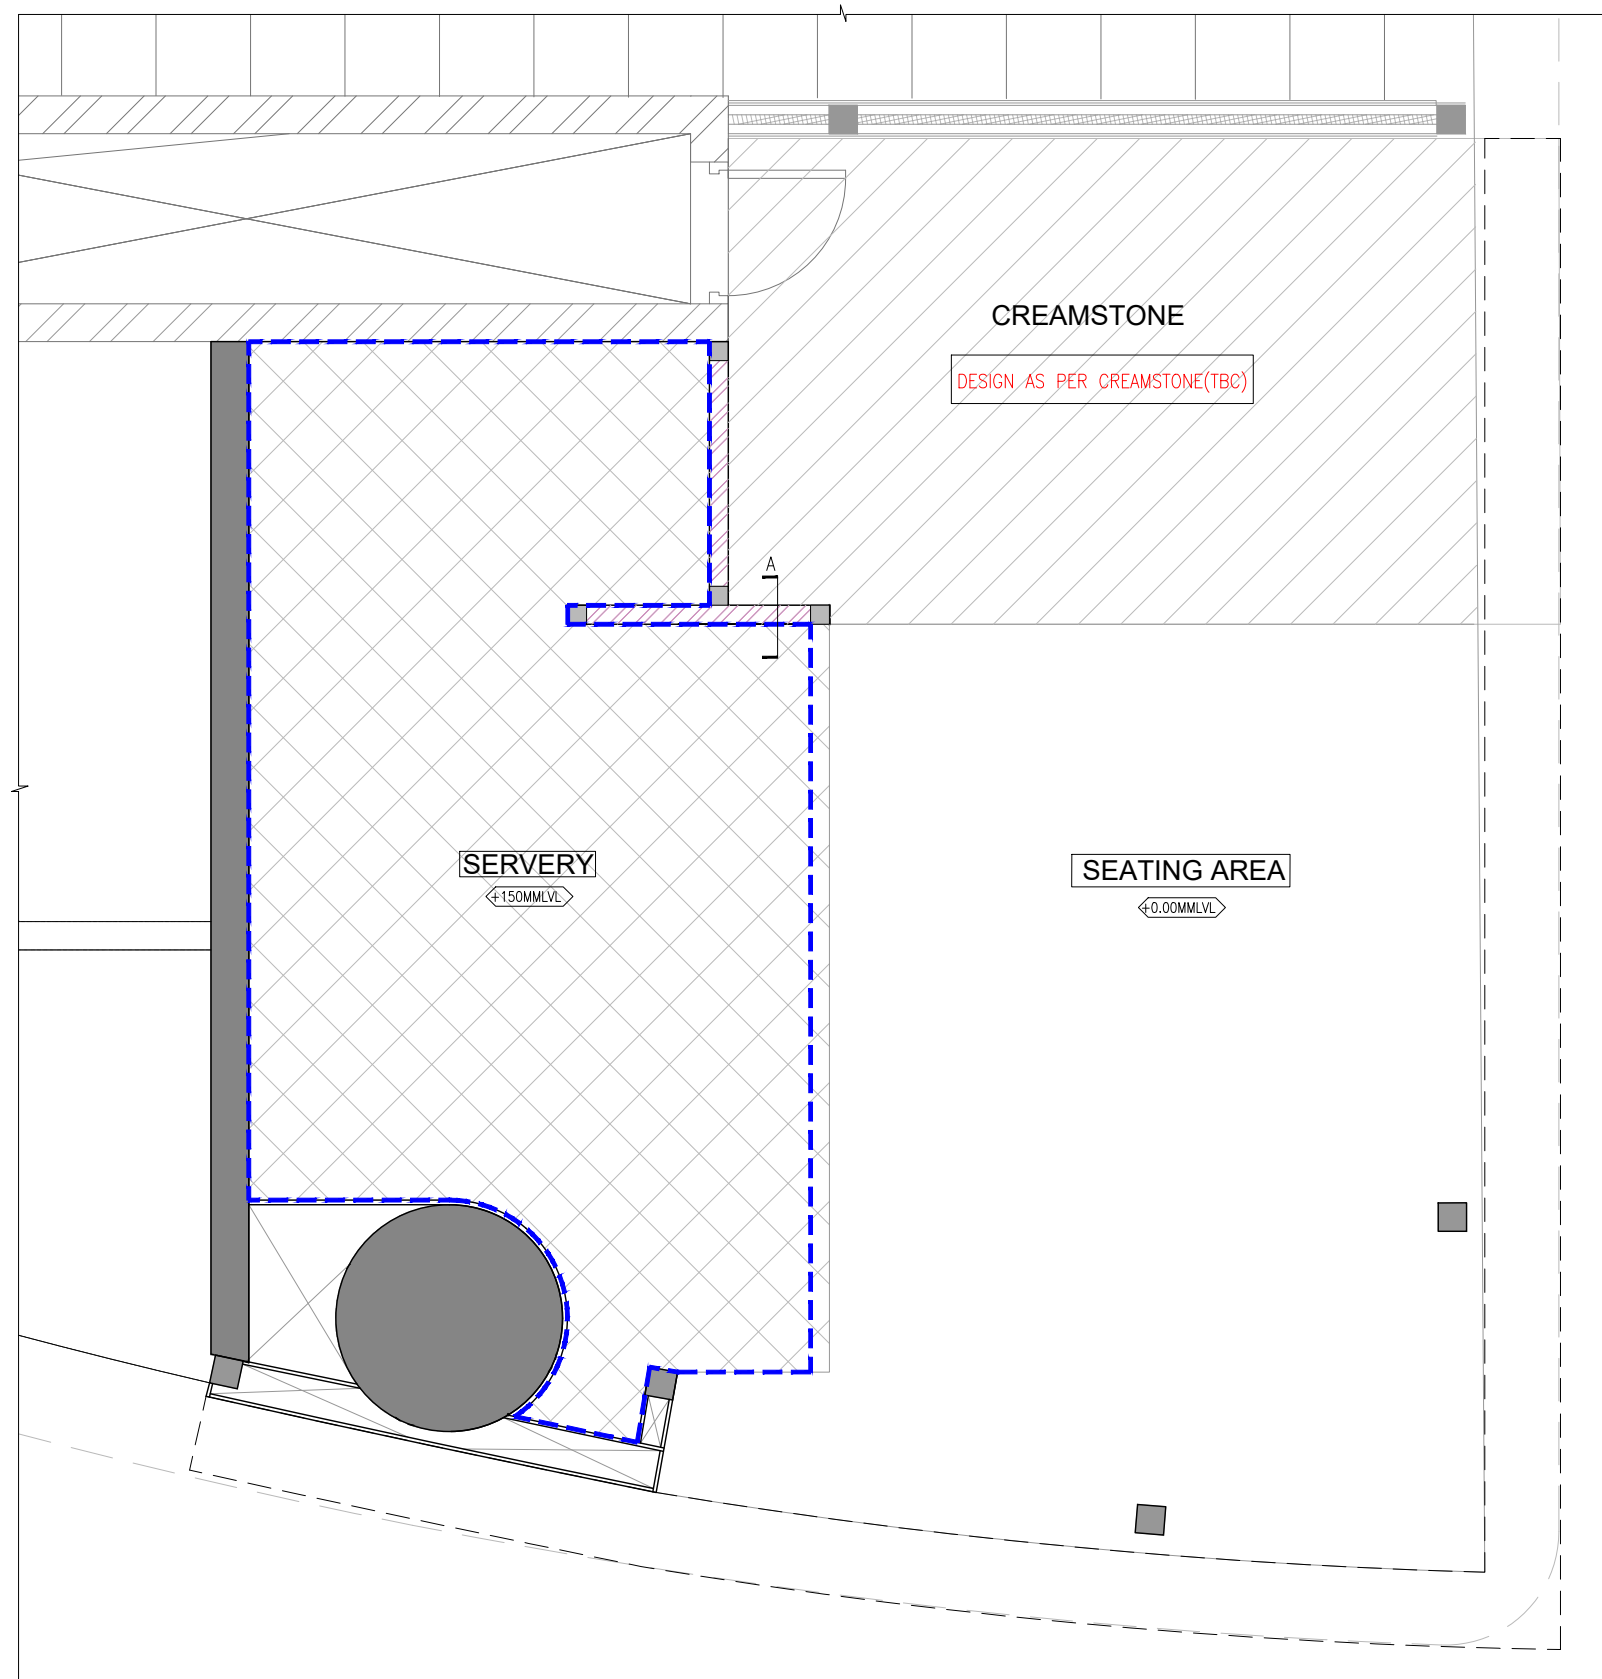

**01 WATER PROOFING LAYOUT**  
02GA-107 1:40

C01	19.02.24	GOOD FOR CONSTRUCTION	HOD	NM
REV	DATE	DESCRIPTION	DRN	CHK




PROJECT  
**FF-045**  
**MILIE COOKIES**  
**HYDERABAD AIRPORT**

DRAWING TITLE  
**WATER PROOFING LAYOUT**

SCALE AS MENTIONED DATE 19.02.2024 DRAWN HOD A3 SHEET

STATUS  
**GOOD FOR CONSTRUCTION**

ORG	PROJECT NO	DRAWING TYPE	NUMBER	REV
TFS	XXXX	02GA	107	C01

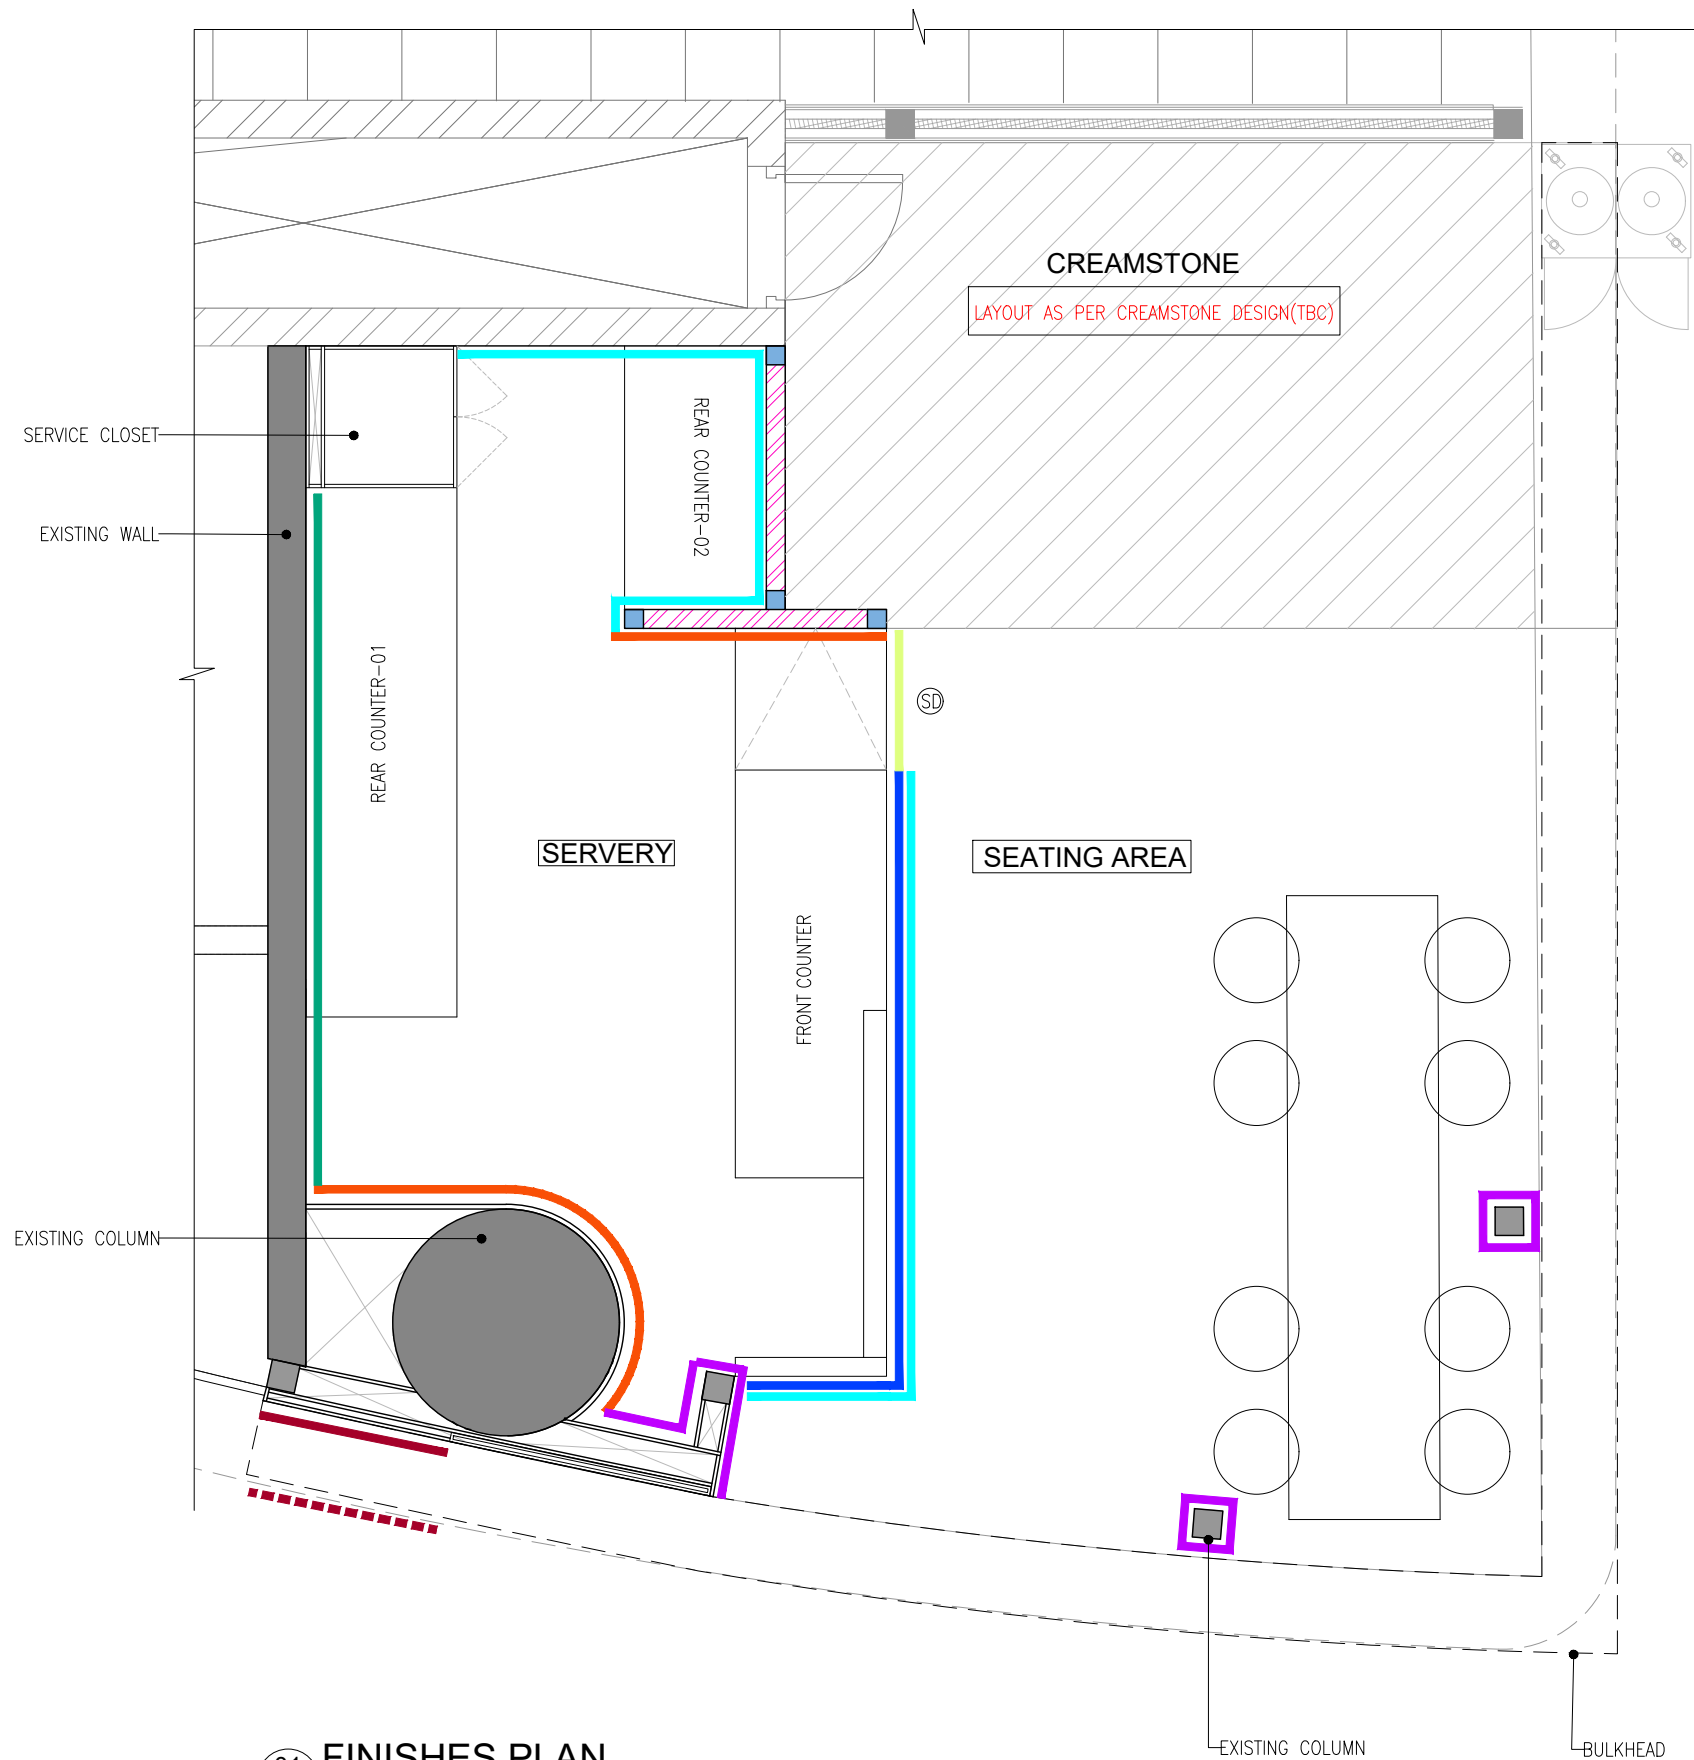

FINISHES LEGEND		
SYMBOL	FINISH	SURFACE
	PT01 WHITE COLOUR PAINT	WALL, FRONT COUNTER
	LM01 WHITE COLOUR LAMINATE	SWING DOOR
	CP01 EMBOSSED CHARCOAL PANEL FINISH WITH WHITE COLOUR PAINT(PT01)	FRONT COUNTER
	WT01 100X100MM WHITE CERAMIC TILE WITH PINK GROUT	WALL
	WT02 100X100MM GREEN SHEEN COLOUR CERAMIC TILE WITH WHITE GROUT	WALL & BOX
	WT03 100X100MM PINK COLOUR CERAMIC TILE WITH WHITE GROUT	BOX & COLUMN
	GR01 VINYL STICKER	BOX & BULKHEAD

01 FINISHES PLAN  
02GA-108 1:40

REV	DATE	DESCRIPTION	HOD	NM
C01	19.02.24	GOOD FOR CONSTRUCTION		



PROJECT  
FF-045  
MILIE COOKIES  
HYDERABAD AIRPORT

DRAWING TITLE  
FINISHES PLAN

SCALE 1:40 DATE 19.02.2024 DRAWN HOD A3 SHEET

STATUS  
GOOD FOR CONSTRUCTION

ORG	PROJECT NO	DRAWING TYPE	NUMBER	REV
TFS	XXXX	02GA	108	C01




DETAIL-A(GR01)  
(SCALE-1:30)



DETAIL-B(GR01)  
(SCALE-1:30)

01 ELEVATION-01  
03L-300 1:40

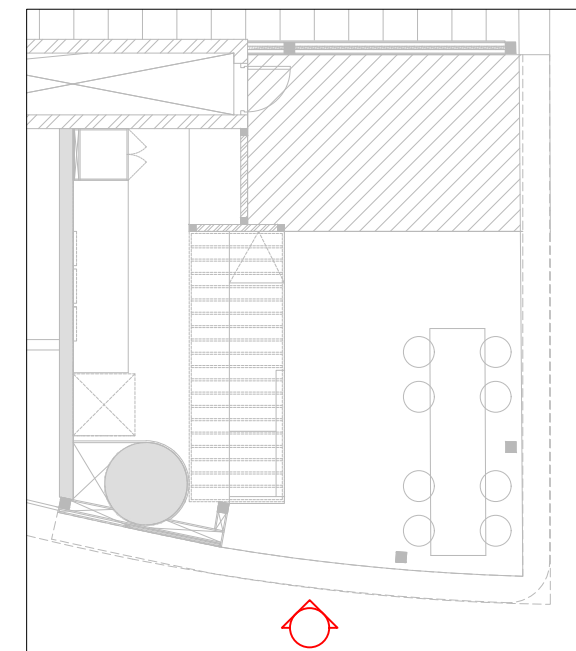

KEYPLAN

REV	DATE	DESCRIPTION	HOD	NM	DRN	CHK
C01	19.02.24	GOOD FOR CONSTRUCTION				




PROJECT  
FF-045  
MILLIE COOKIES  
HYDERABAD AIRPORT

DRAWING TITLE  
ELEVATION-01


SCALE AS MENTIONED DATE 19.02.2024 DRAWN HOD A3 SHEET

STATUS  
GOOD FOR CONSTRUCTION

ORG	PROJECT NO	DRAWING TYPE	NUMBER	REV
TFS	XXXX	03IL	300	C01

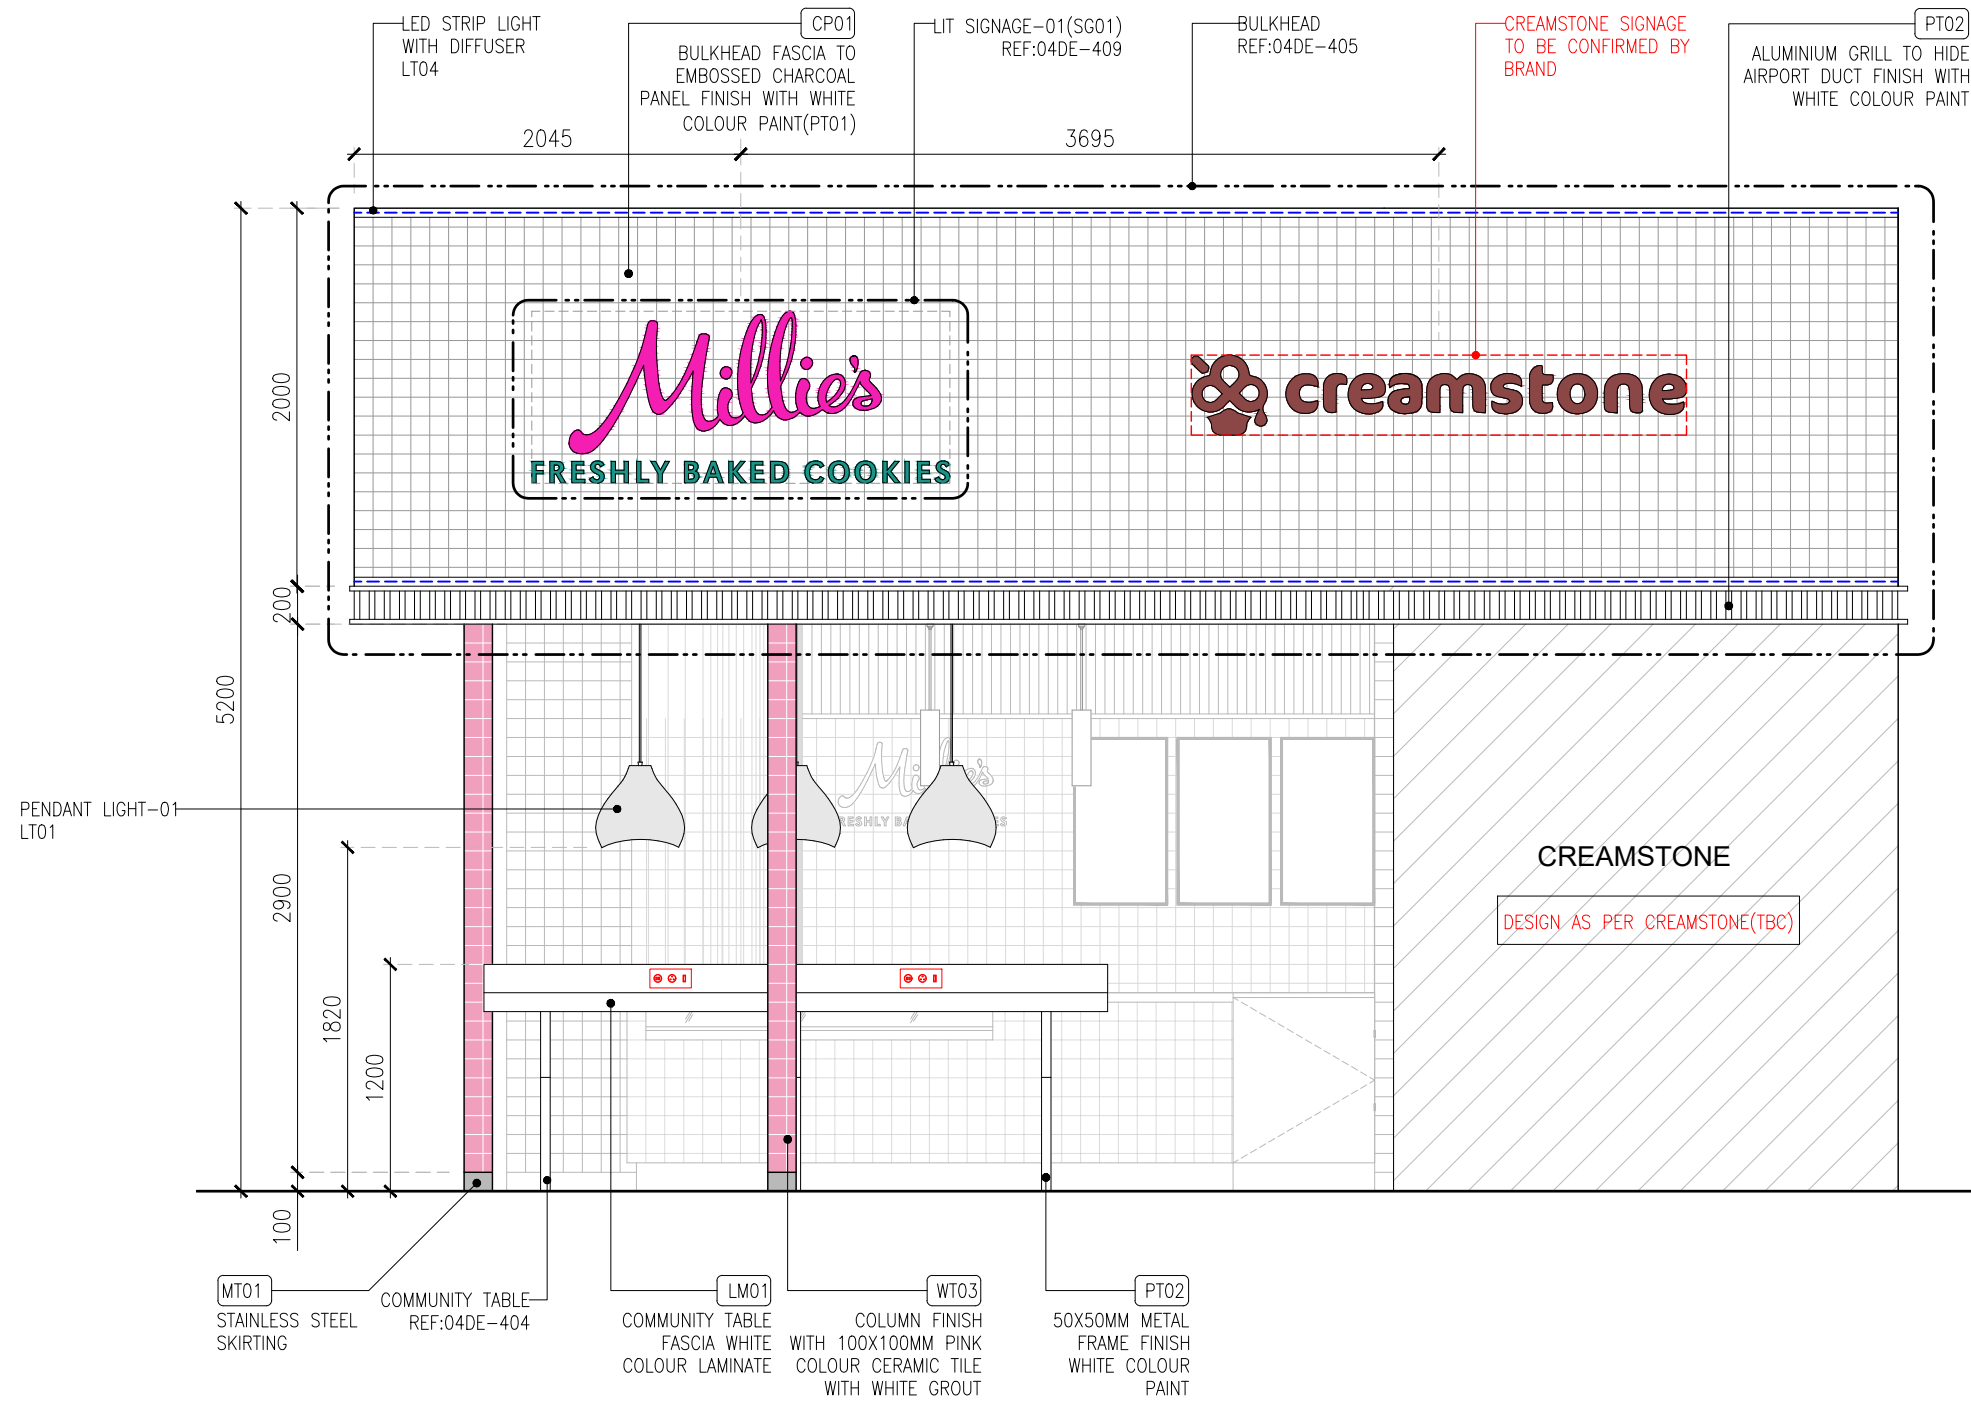

01 ELEVATION - 02  
03IL-3011:40

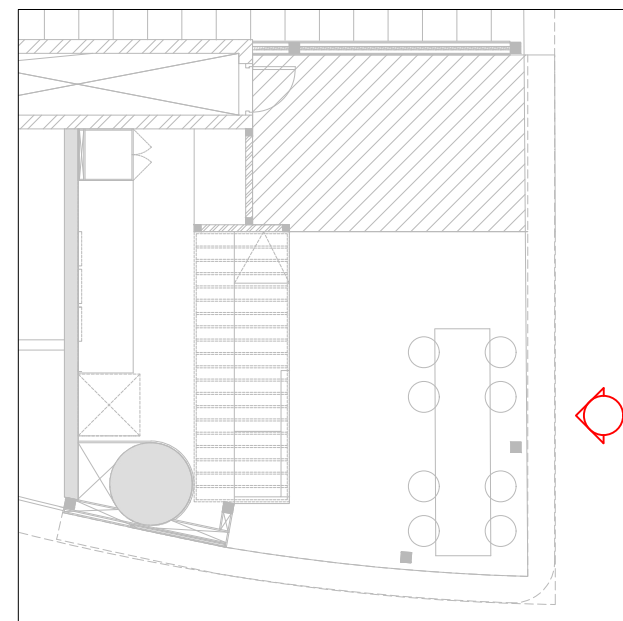

KEY PLAN

REV	DATE	DESCRIPTION	HOD	NM
C01	19.02.24	GOOD FOR CONSTRUCTION		



PROJECT  
FF-045  
MILLIE COOKIES  
HYDERABAD AIRPORT


DRAWING TITLE  
ELEVATION - 02

SCALE 1:40 DATE 19.02.2024 DRAWN HOD A3 SHEET

STATUS  
GOOD FOR CONSTRUCTION

ORG	PROJECT NO	DRAWING TYPE	NUMBER	REV
TFS	XXXX 03IL	301	C01	



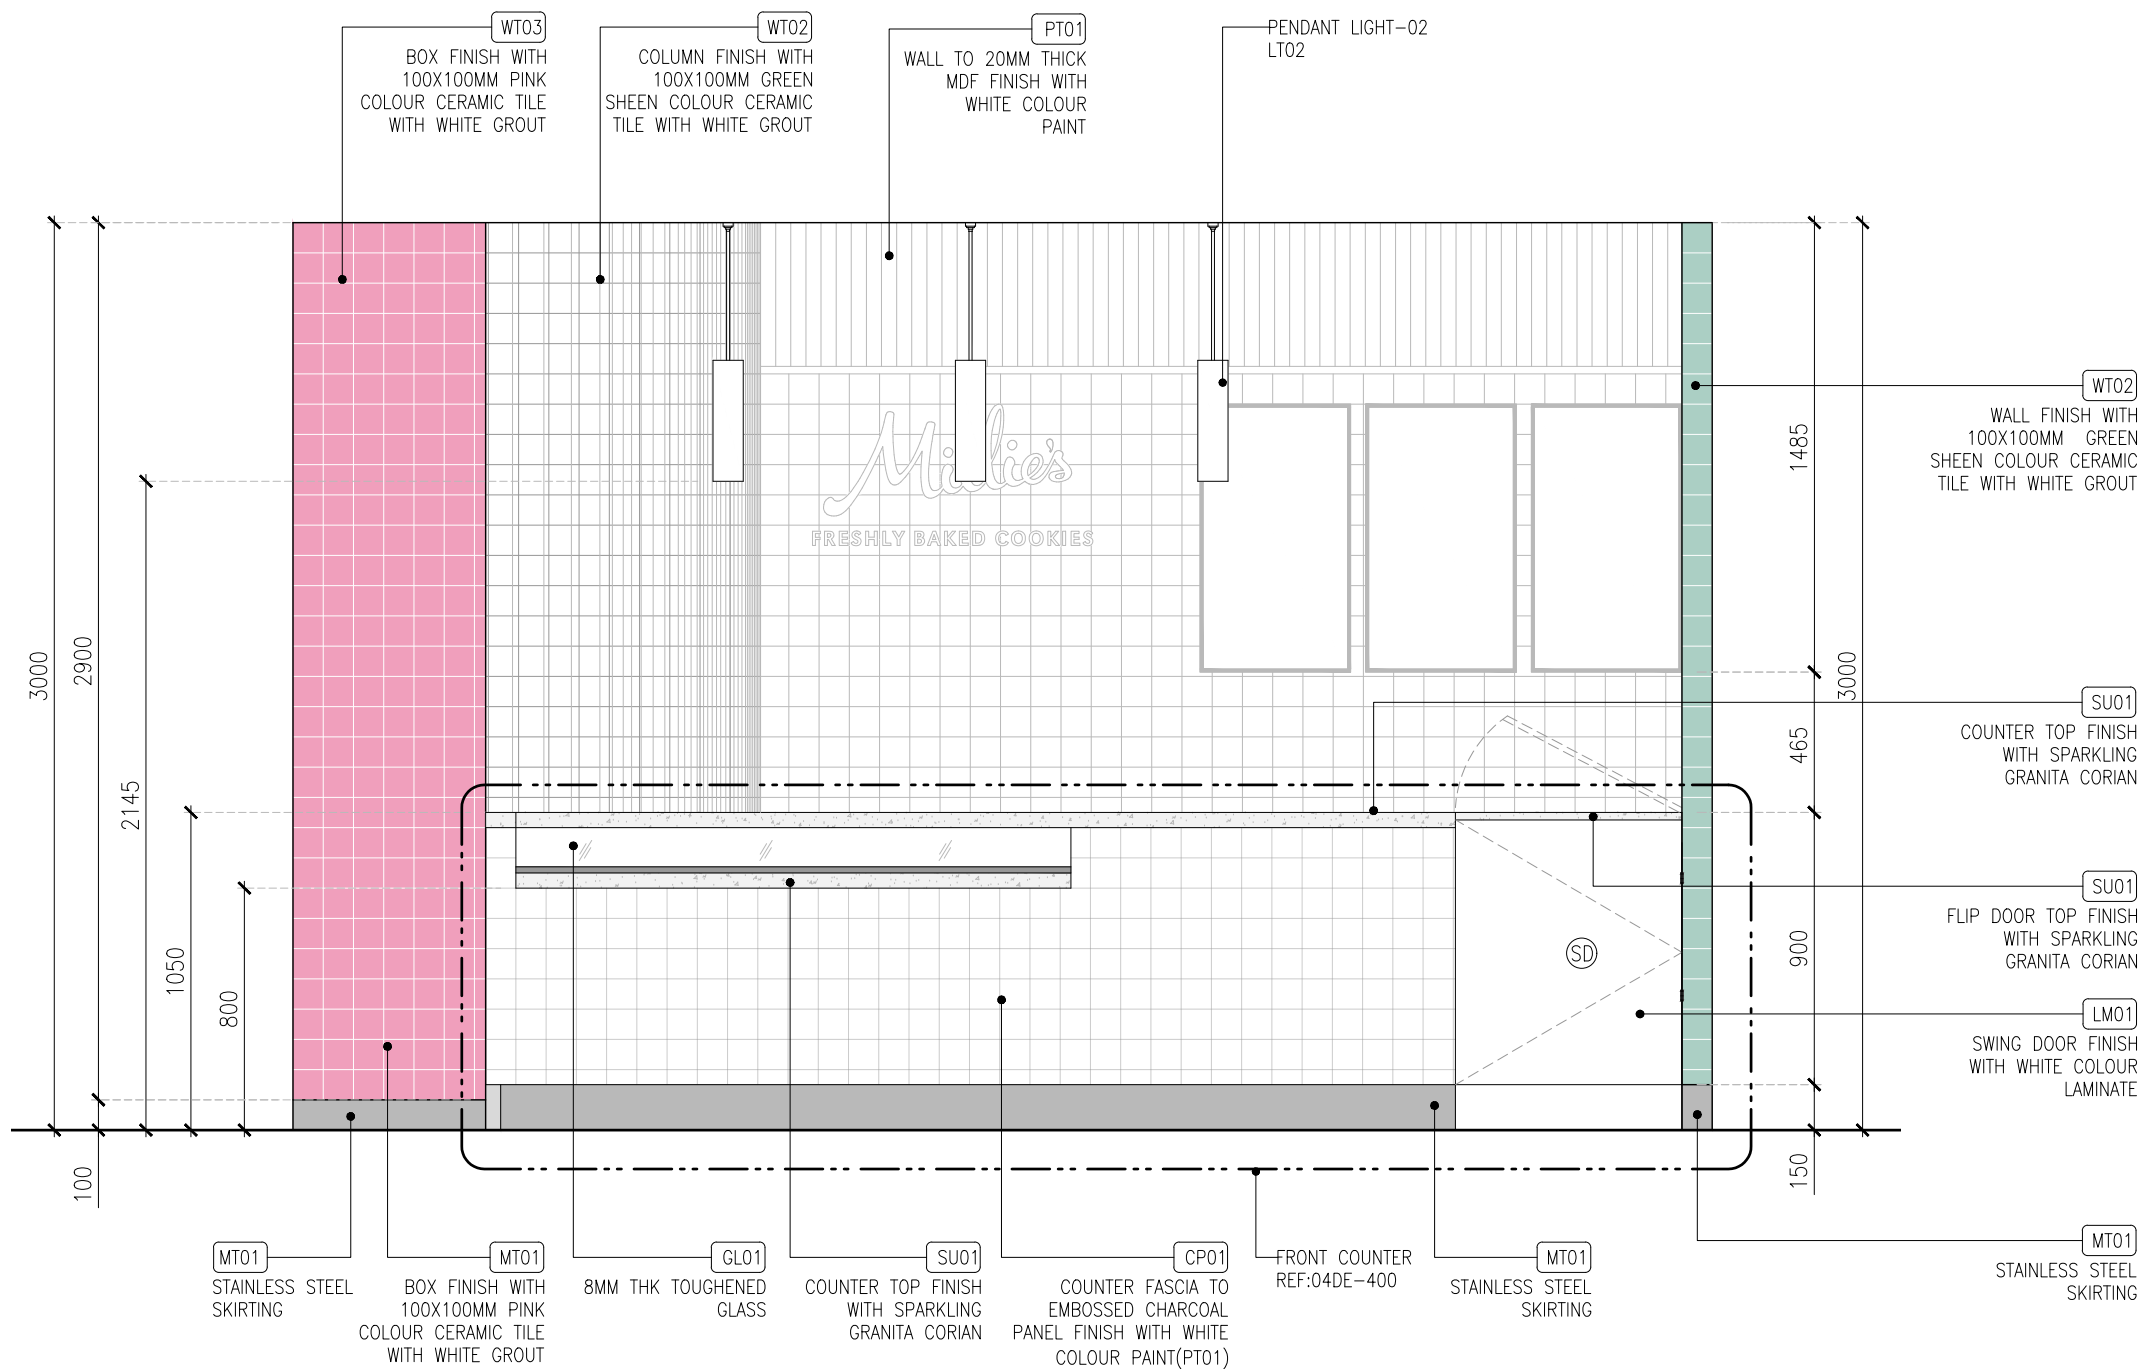

01 ELEVATION - 03  
03IL-302 1:25

REV	DATE	DESCRIPTION	HOD	NM	DRN	CHK
C01	19.02.24	GOOD FOR CONSTRUCTION				




PROJECT  
FF-045  
MILIE COOKIES  
HYDERABAD AIRPORT

DRAWING TITLE  
ELEVATION - 03


SCALE 1:25 DATE 19.02.2024 DRAWN HOD A3 SHEET

STATUS  
GOOD FOR CONSTRUCTION


ORG	PROJECT NO	DRAWING TYPE	NUMBER	REV
TFS	XXXX 03IL	302	C01	

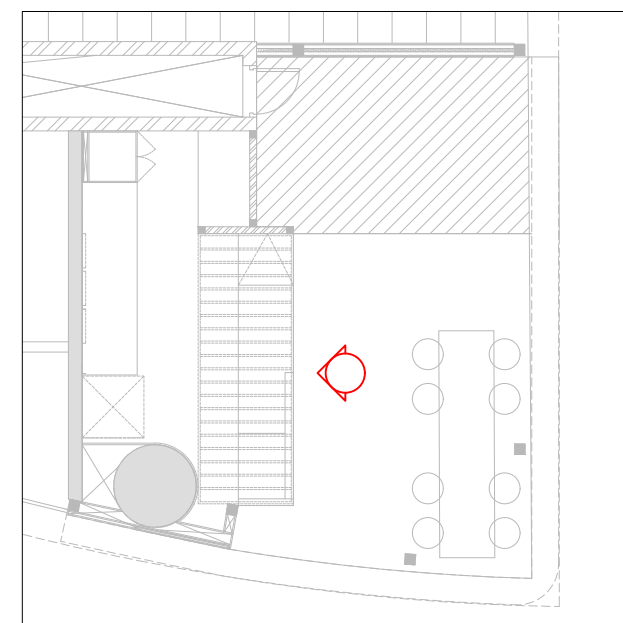

KEY PLAN

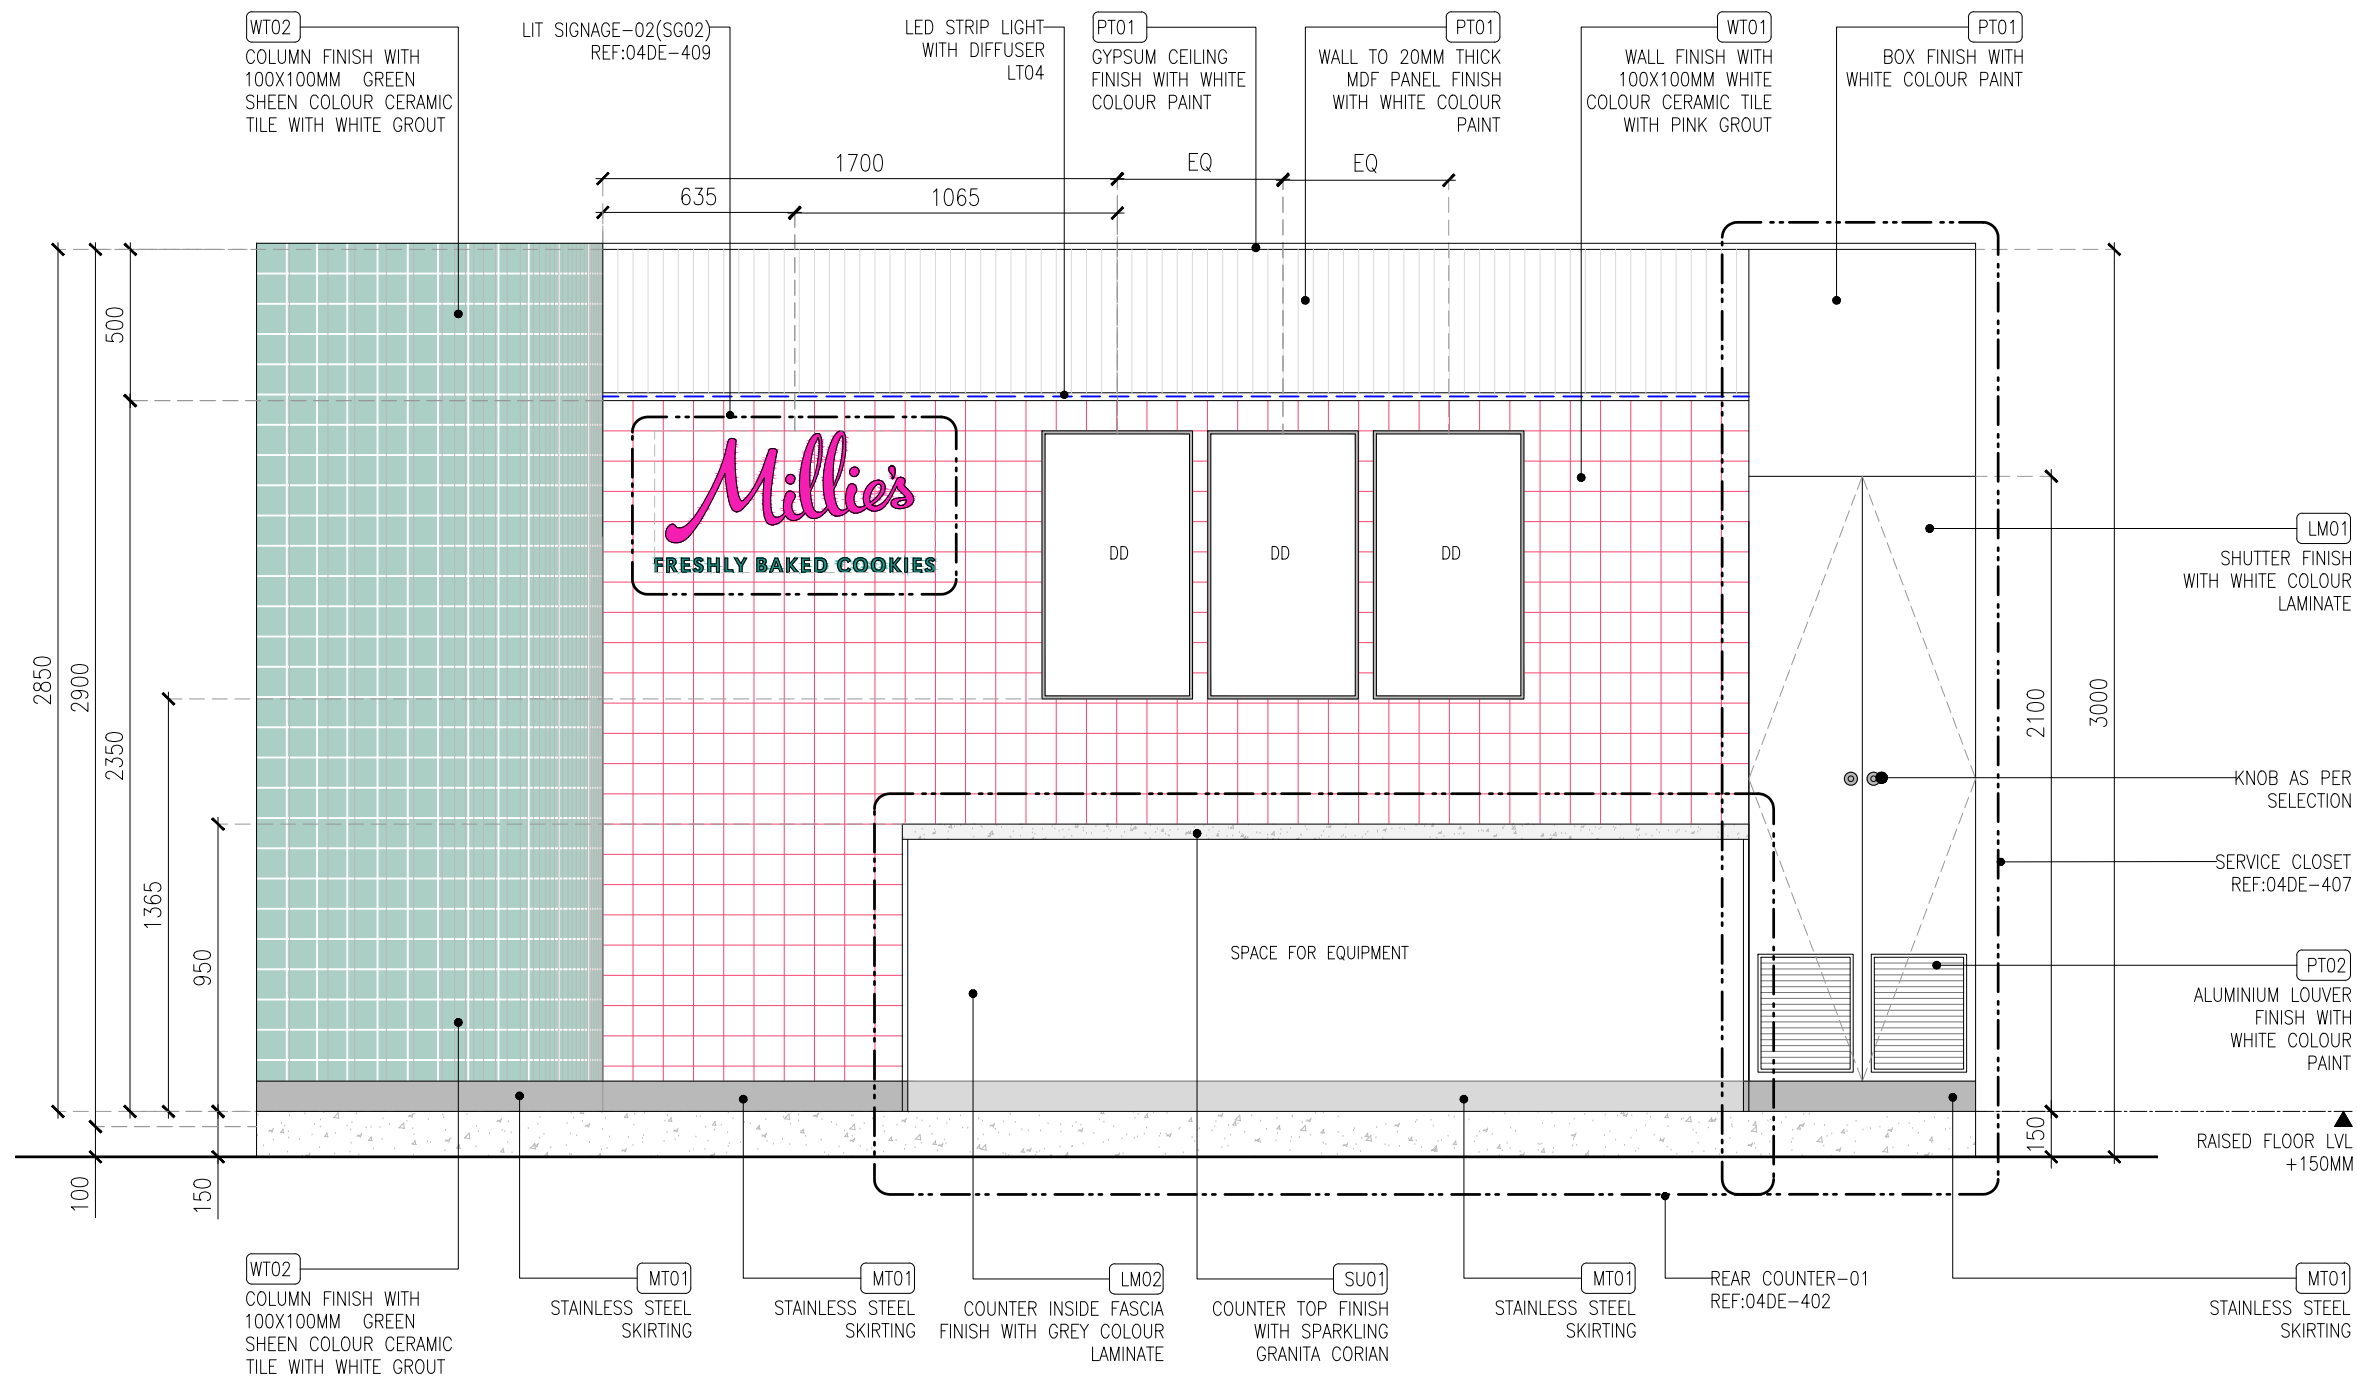

01 ELEVATION-04  
03IL-303 1:25

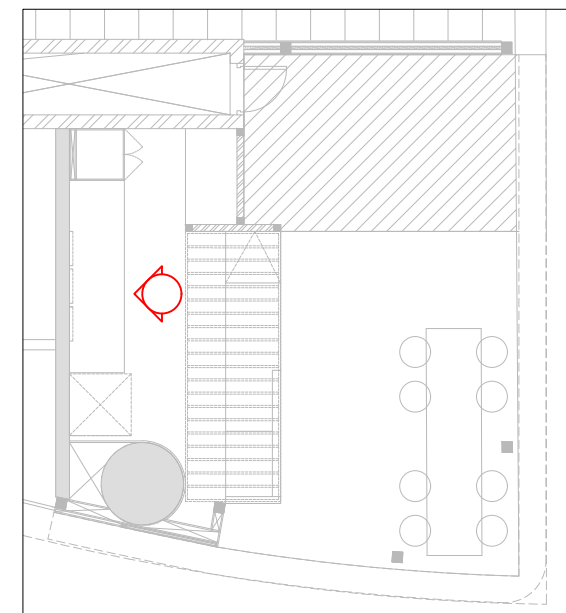

KEYPLAN

C01	19.02.24	GOOD FOR CONSTRUCTION	HOD	NM
REV	DATE	DESCRIPTION	DRN	CHK




PROJECT  
FF-045  
MILLIE COOKIES  
HYDERABAD AIRPORT

DRAWING TITLE  
ELEVATION-04

SCALE 1:25 DATE 19.02.2024 DRAWN HOD A3 SHEET

STATUS  
GOOD FOR CONSTRUCTION

ORG	PROJECT NO	DRAWING TYPE	NUMBER	REV
TFS	XXXX	03IL	303	C01

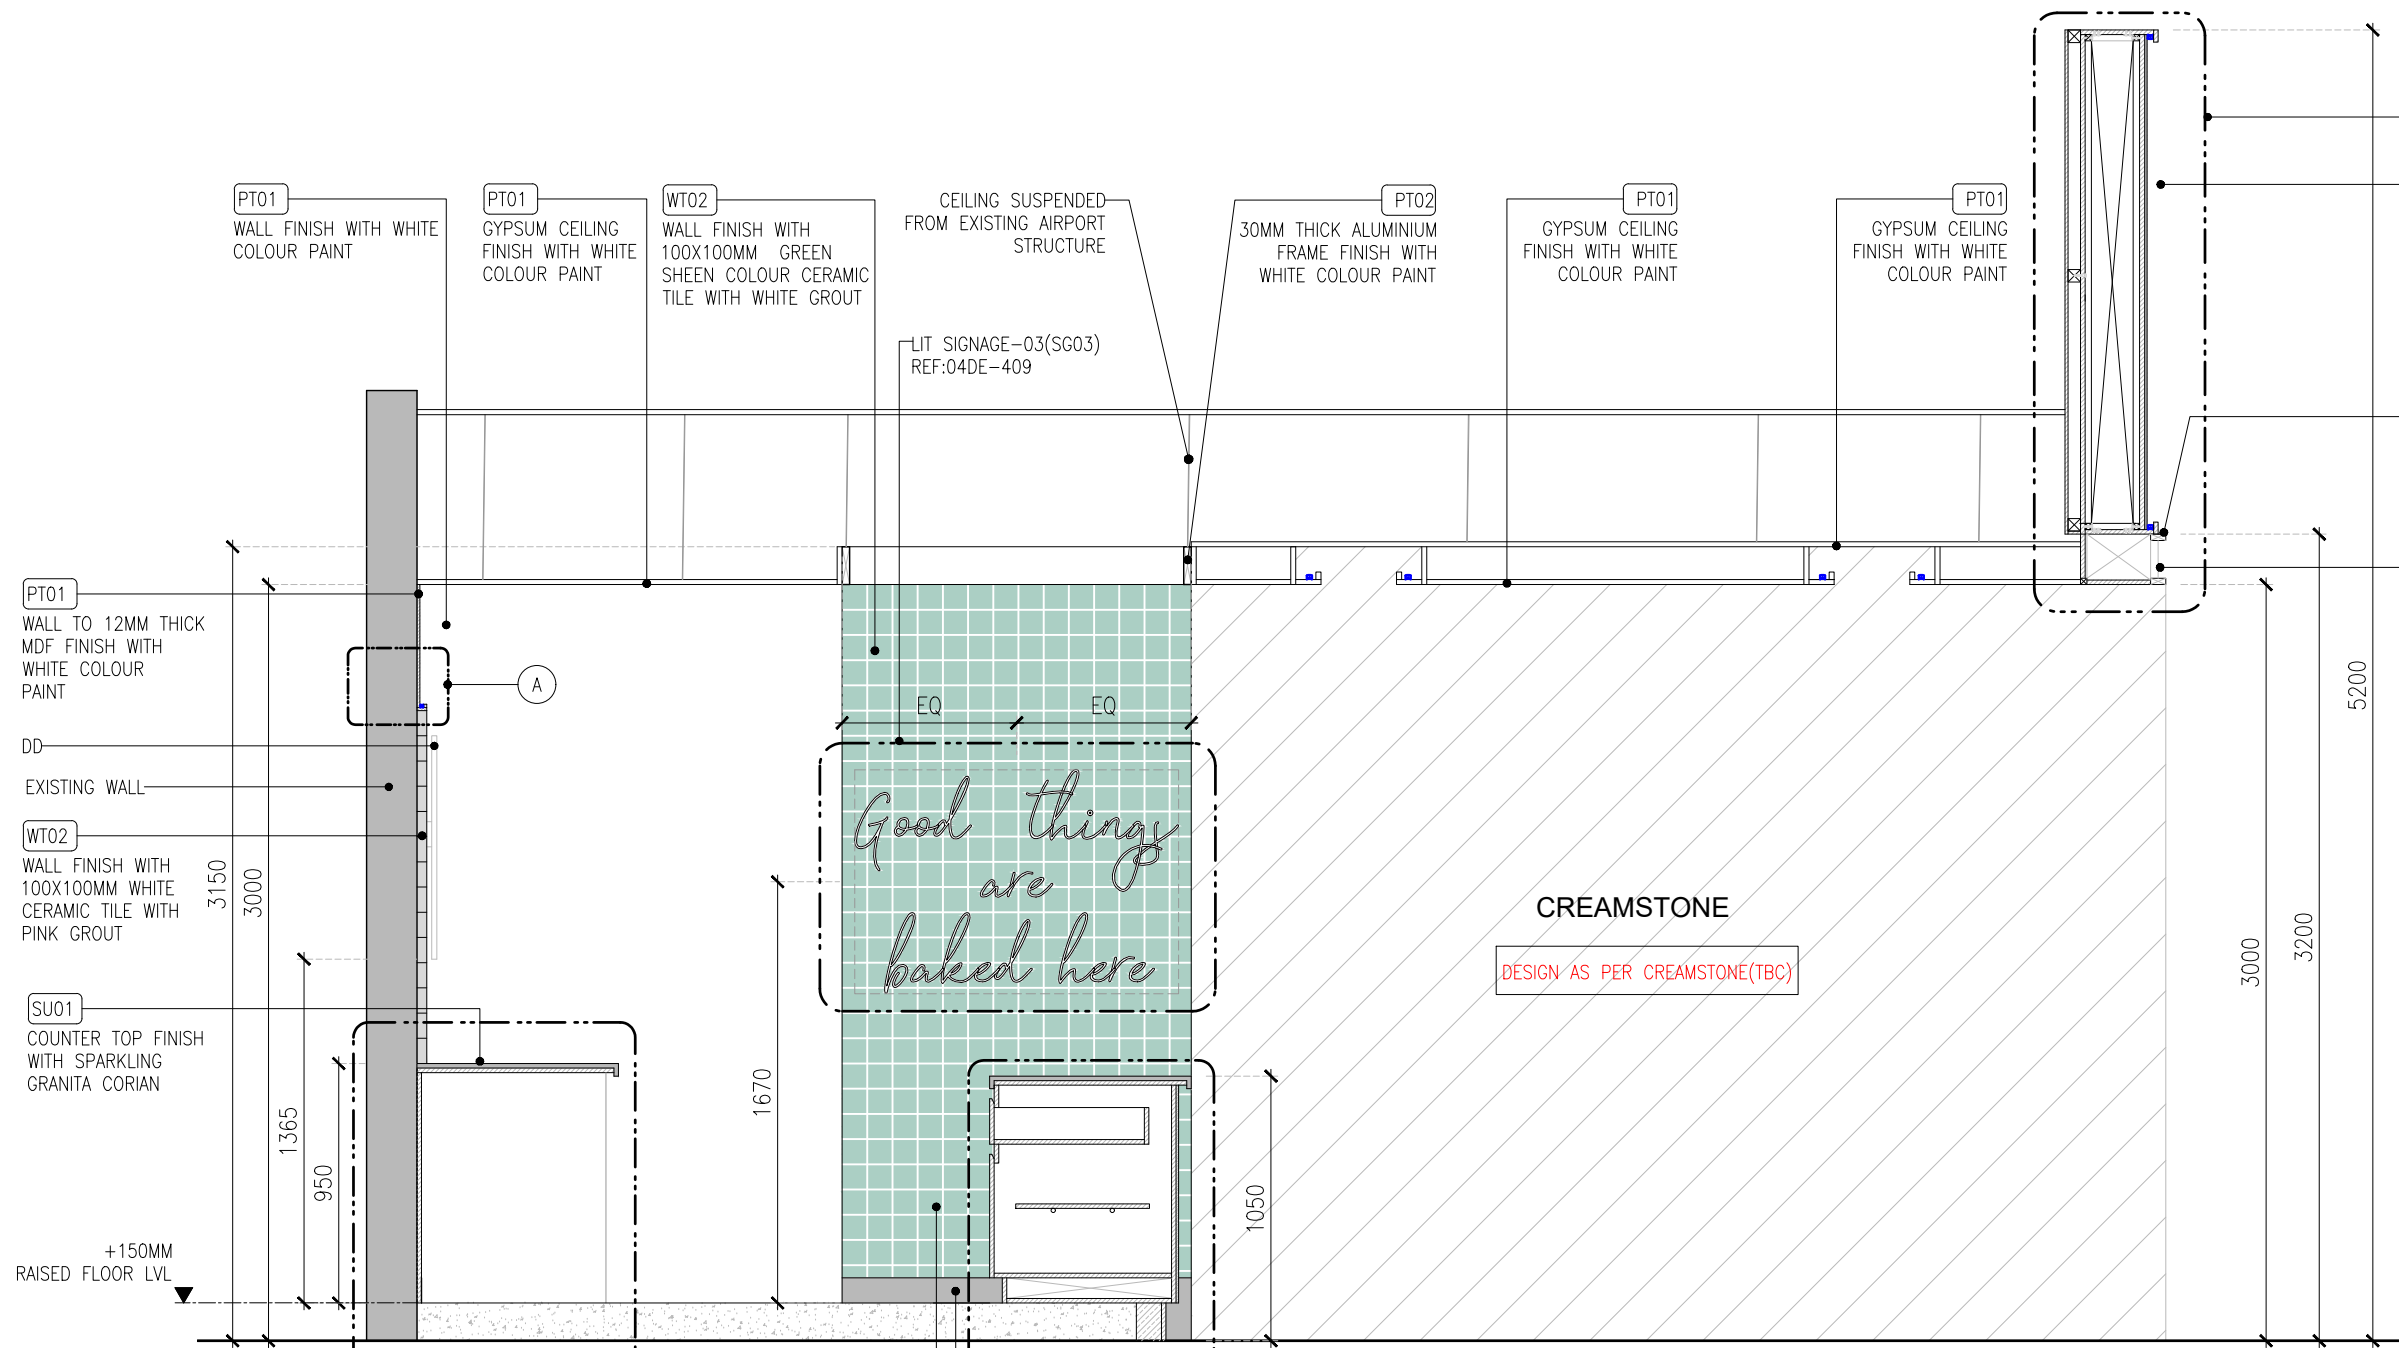

- REF:04DE-405
- CP01 BULKHEAD FASCIA TO EMBOSSED CHARCOAL PANEL FINISH WITH WHITE COLOUR PAINT(PT01)
- PT02 60X25MM ALUMINIUM RECTANGULAR TUBE FINISH WITH WHITE COLOUR PAINT
- PT02 ALUMINIUM GRILL TO HIDE AIRPORT DUCT FINISH WITH WHITE COLOUR PAINT


- PT01 WALL TO 12MM THICK MDF FINISH WITH WHITE COLOUR PAINT
- DD EXISTING WALL
- WT02 WALL FINISH WITH 100X100MM WHITE CERAMIC TILE WITH PINK GROUT
- SU01 COUNTER TOP FINISH WITH SPARKLING GRANITA CORIAN

*Good things are baked here*

CREAMSTONE  
DESIGN AS PER CREAMSTONE(TBC)


- REAR COUNTER-01 REF:04DE-402
- WT02 WALL FINISH WITH 100X100MM GREEN SHEEN COLOUR CERAMIC TILE WITH WHITE GROUT
- MT01 STAINLESS STEEL SKIRTING
- FRONT COUNTER REF:04DE-400

01 SECTION -01  
03IL-304 1:30

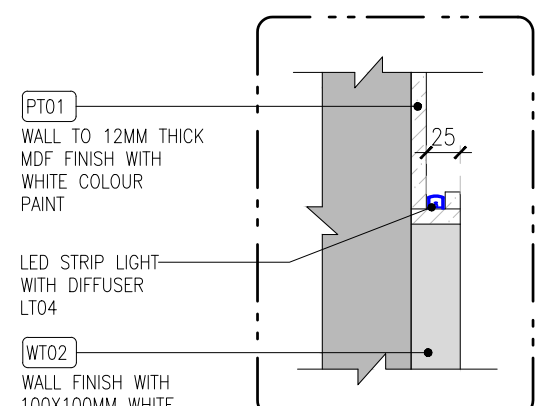

- PT01 WALL TO 12MM THICK MDF FINISH WITH WHITE COLOUR PAINT
- LED STRIP LIGHT WITH DIFFUSER LT04
- WT02 WALL FINISH WITH 100X100MM WHITE CERAMIC TILE WITH PINK GROUT

DETAIL-A (SCALE 1:10)

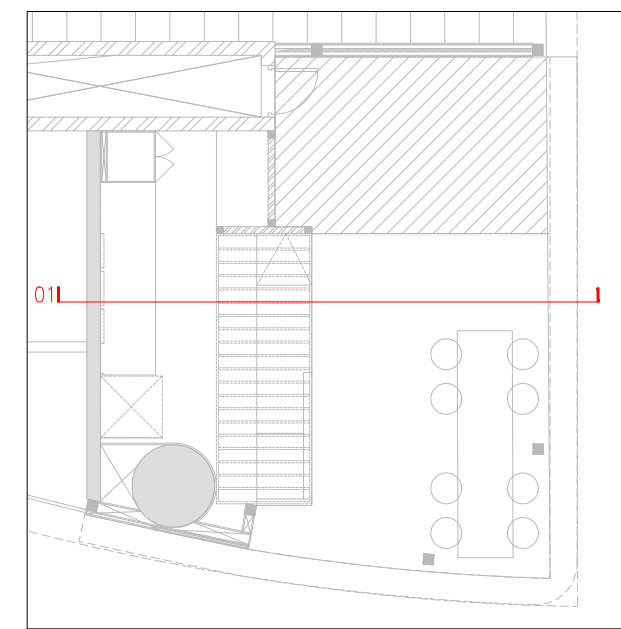

KEY PLAN

REV DATE	DESCRIPTION	HOD NM	DRN CHK
C01 19.02.24	GOOD FOR CONSTRUCTION		







PROJECT  
**FF-045**  
**MILIE COOKIES**  
**HYDERABAD AIRPORT**

DRAWING TITLE  
**SECTION-01**

SCALE 1:30 DATE 19.02.2024 DRAWN HOD A3 SHEET

STATUS  
**GOOD FOR CONSTRUCTION**

ORG	PROJECT NO	DRAWING TYPE	NUMBER	REV
TFS	XXXX 03IL	304	C01	

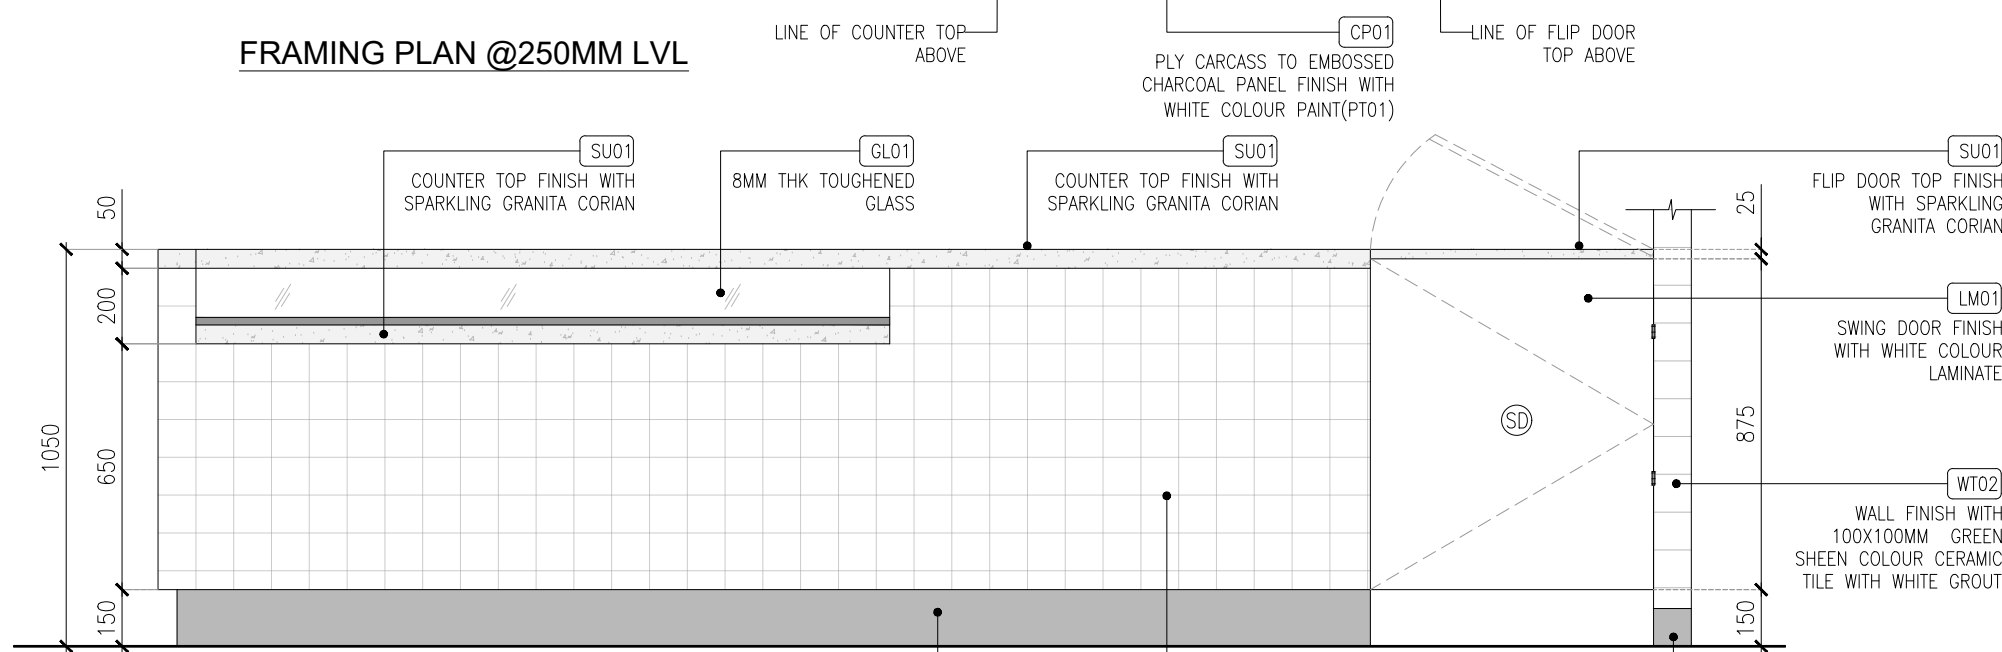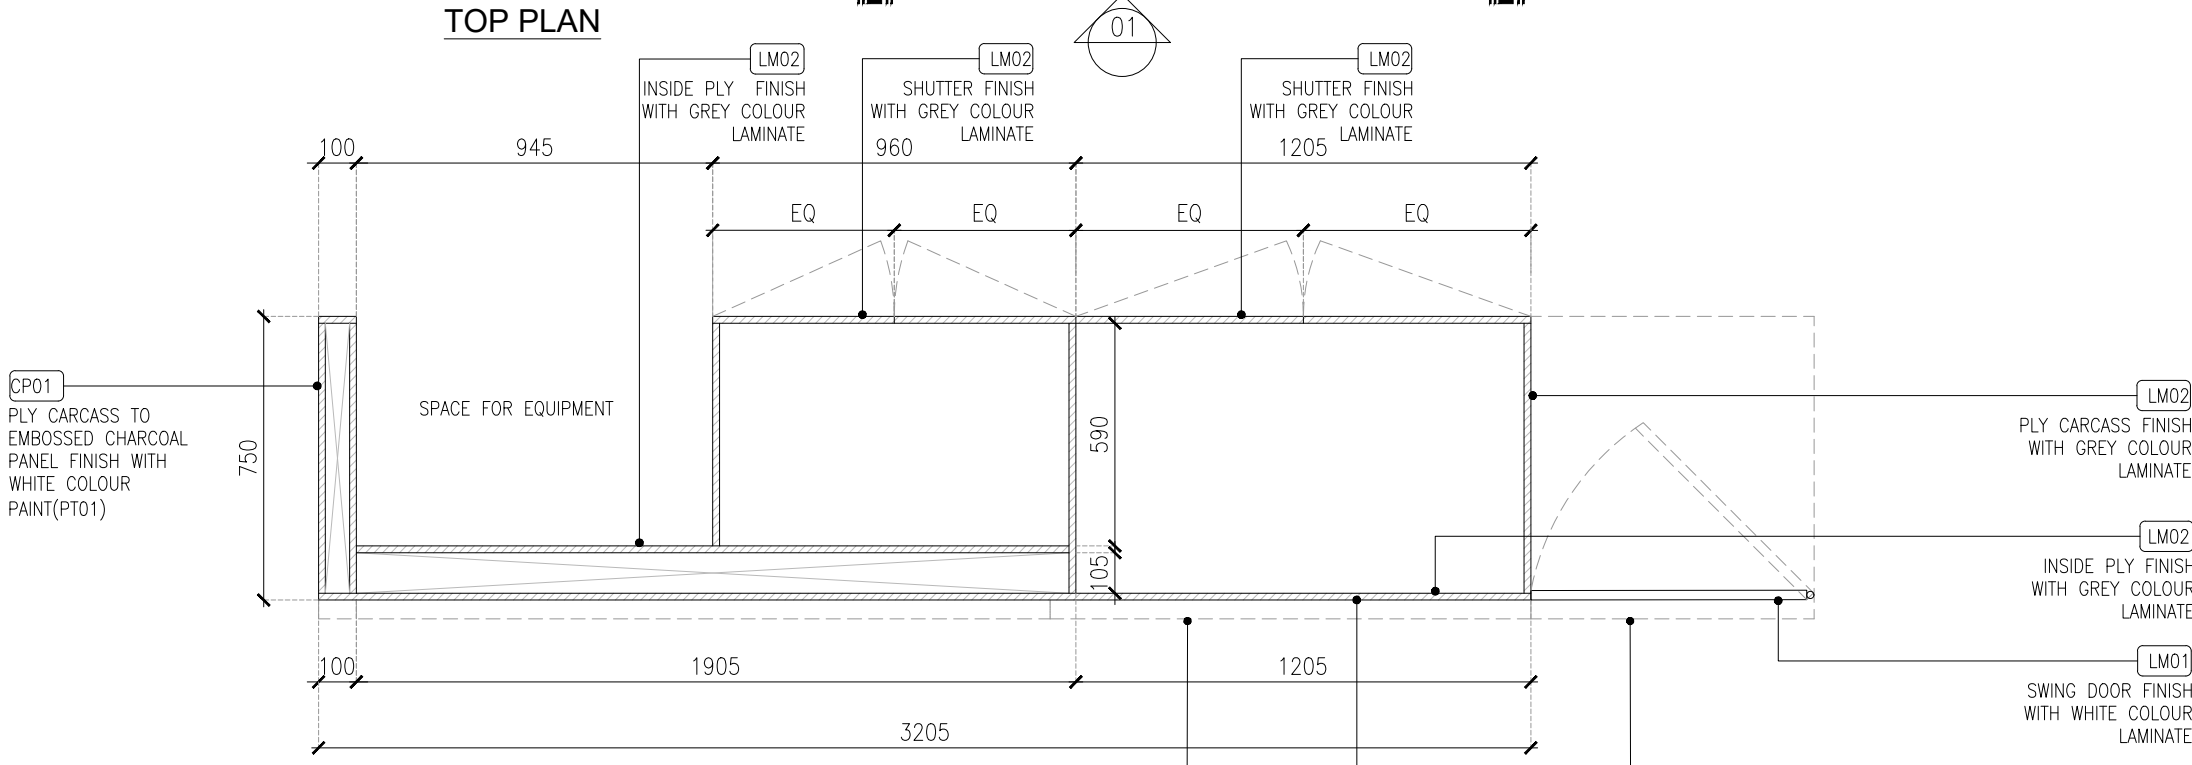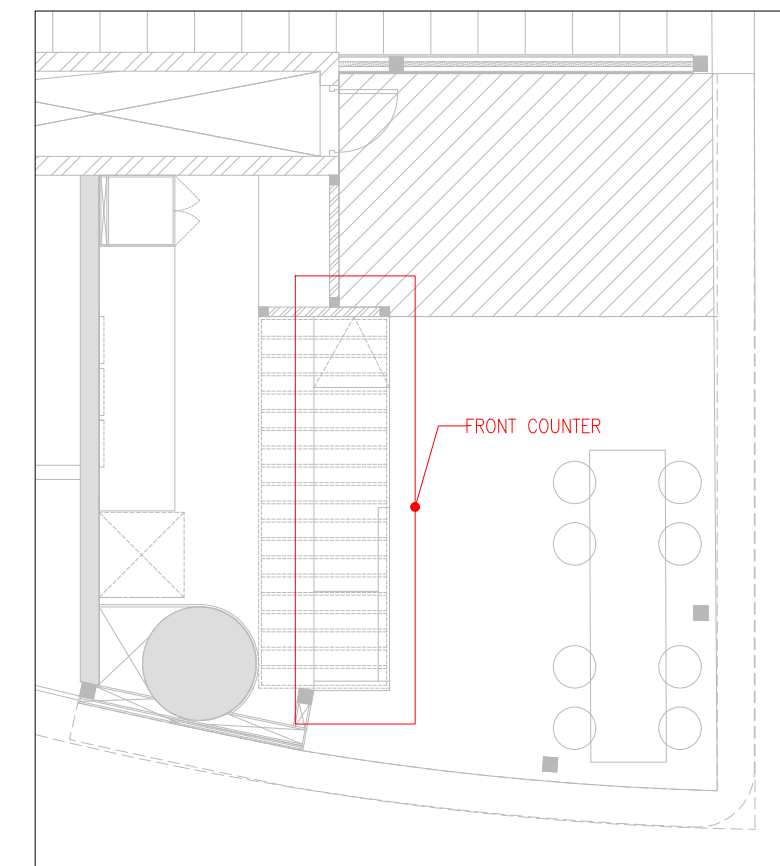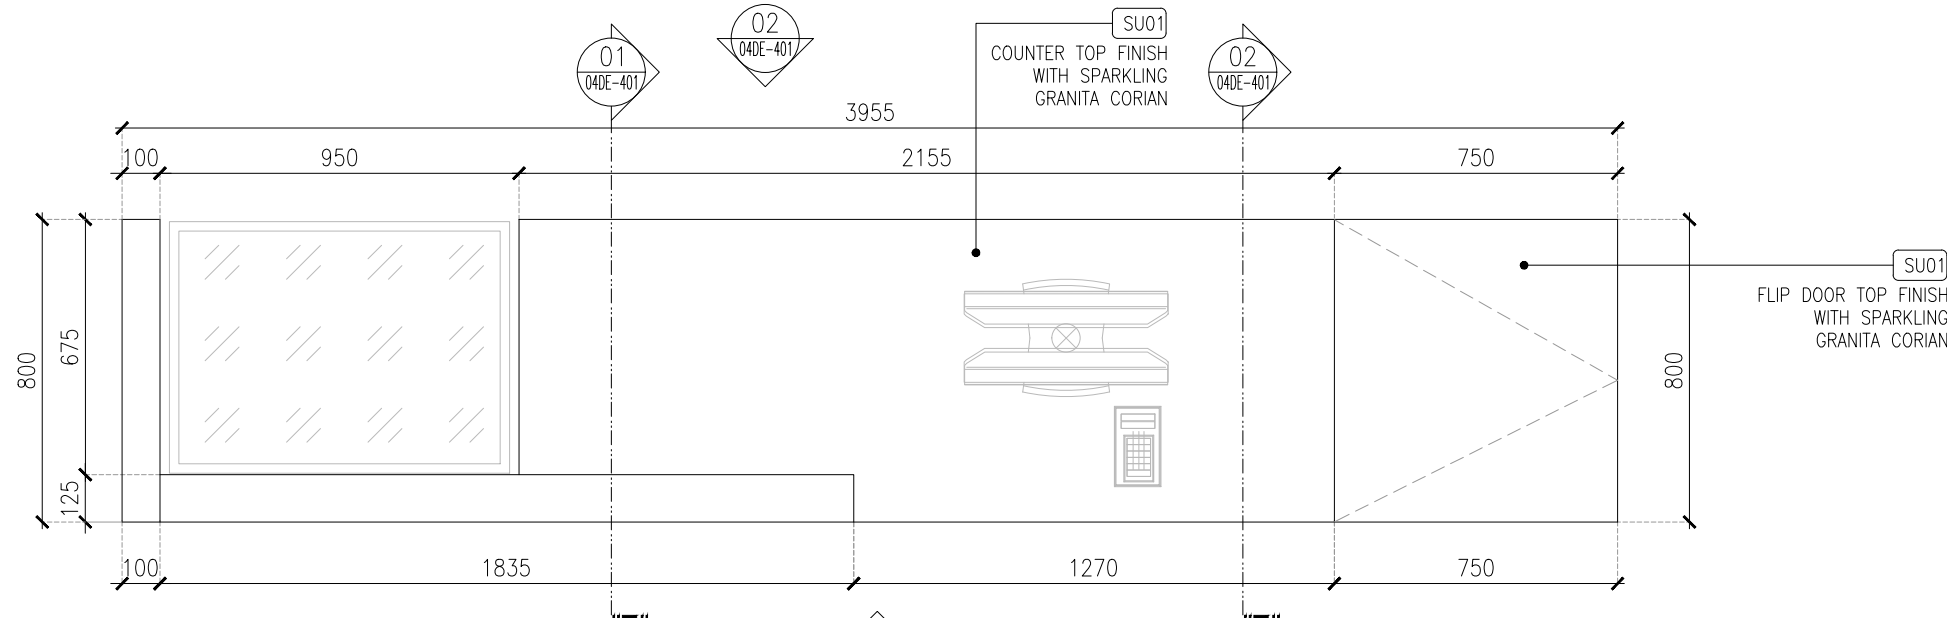

CP01  
PLY CARCASS TO  
EMBOSSED CHARCOAL  
PANEL FINISH WITH  
WHITE COLOUR  
PAINT(PT01)

**01 04DE-400 1:20 J01-FRONT COUNTER DETAIL PART-A**

REV	DATE	DESCRIPTION	HOD	NM
C01	19.02.24	GOOD FOR CONSTRUCTION		
			DRN	CHK







PROJECT  
**FF-045**  
**MILIE COOKIES**  
**HYDERABAD AIRPORT**

DRAWING TITLE  
**J01-FRONT COUNTER DETAIL PART-A**

SCALE 1:20 DATE 19.02.2024 DRAWN HOD A3 SHEET

STATUS  
**GOOD FOR CONSTRUCTION**

ORG	PROJECT NO	DRAWING TYPE	NUMBER	REV
TFS	XXXX	04DE	400	C01

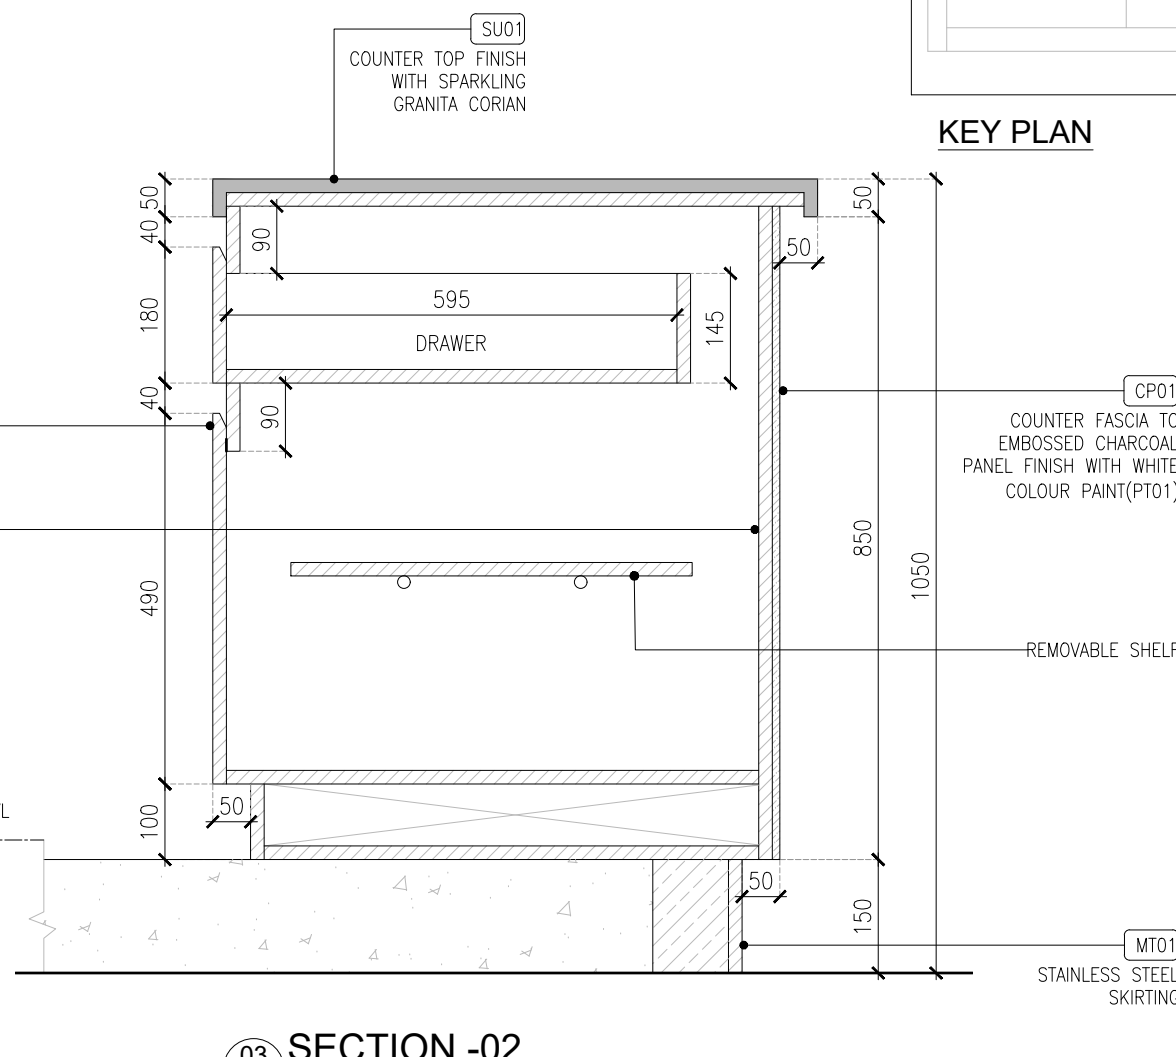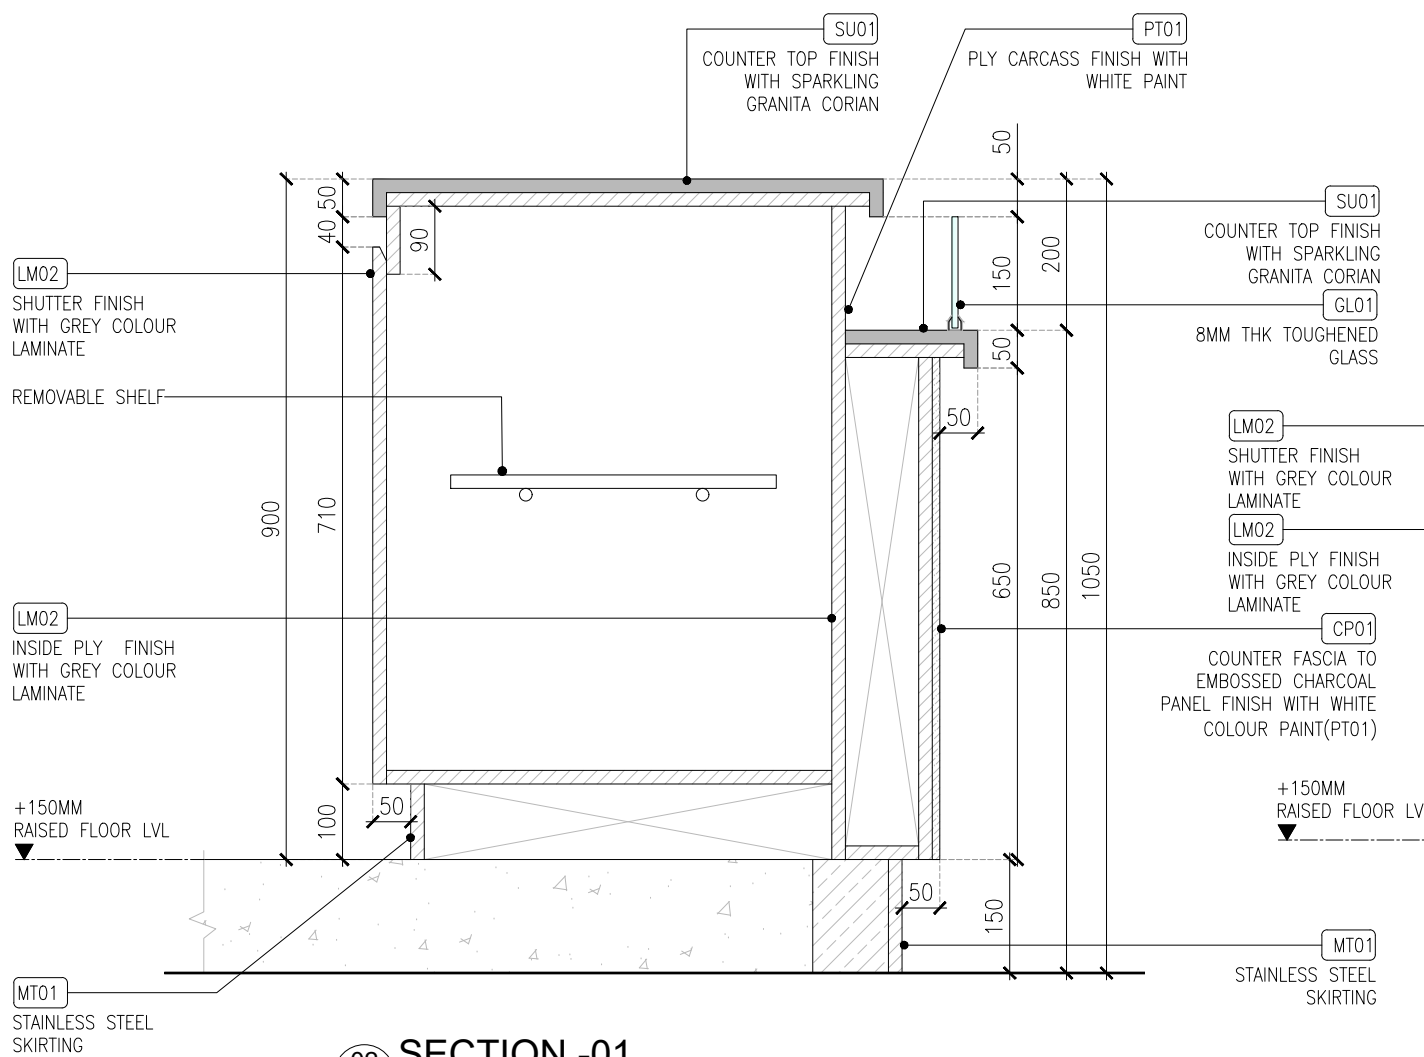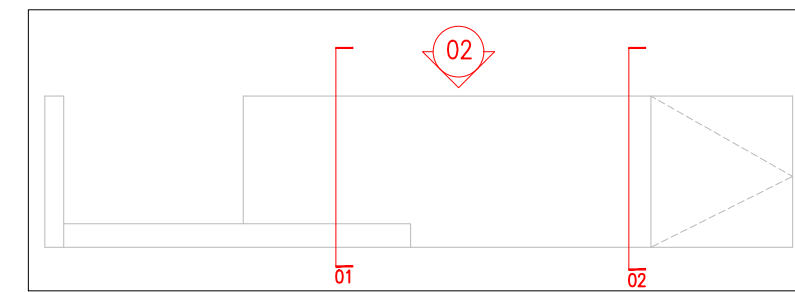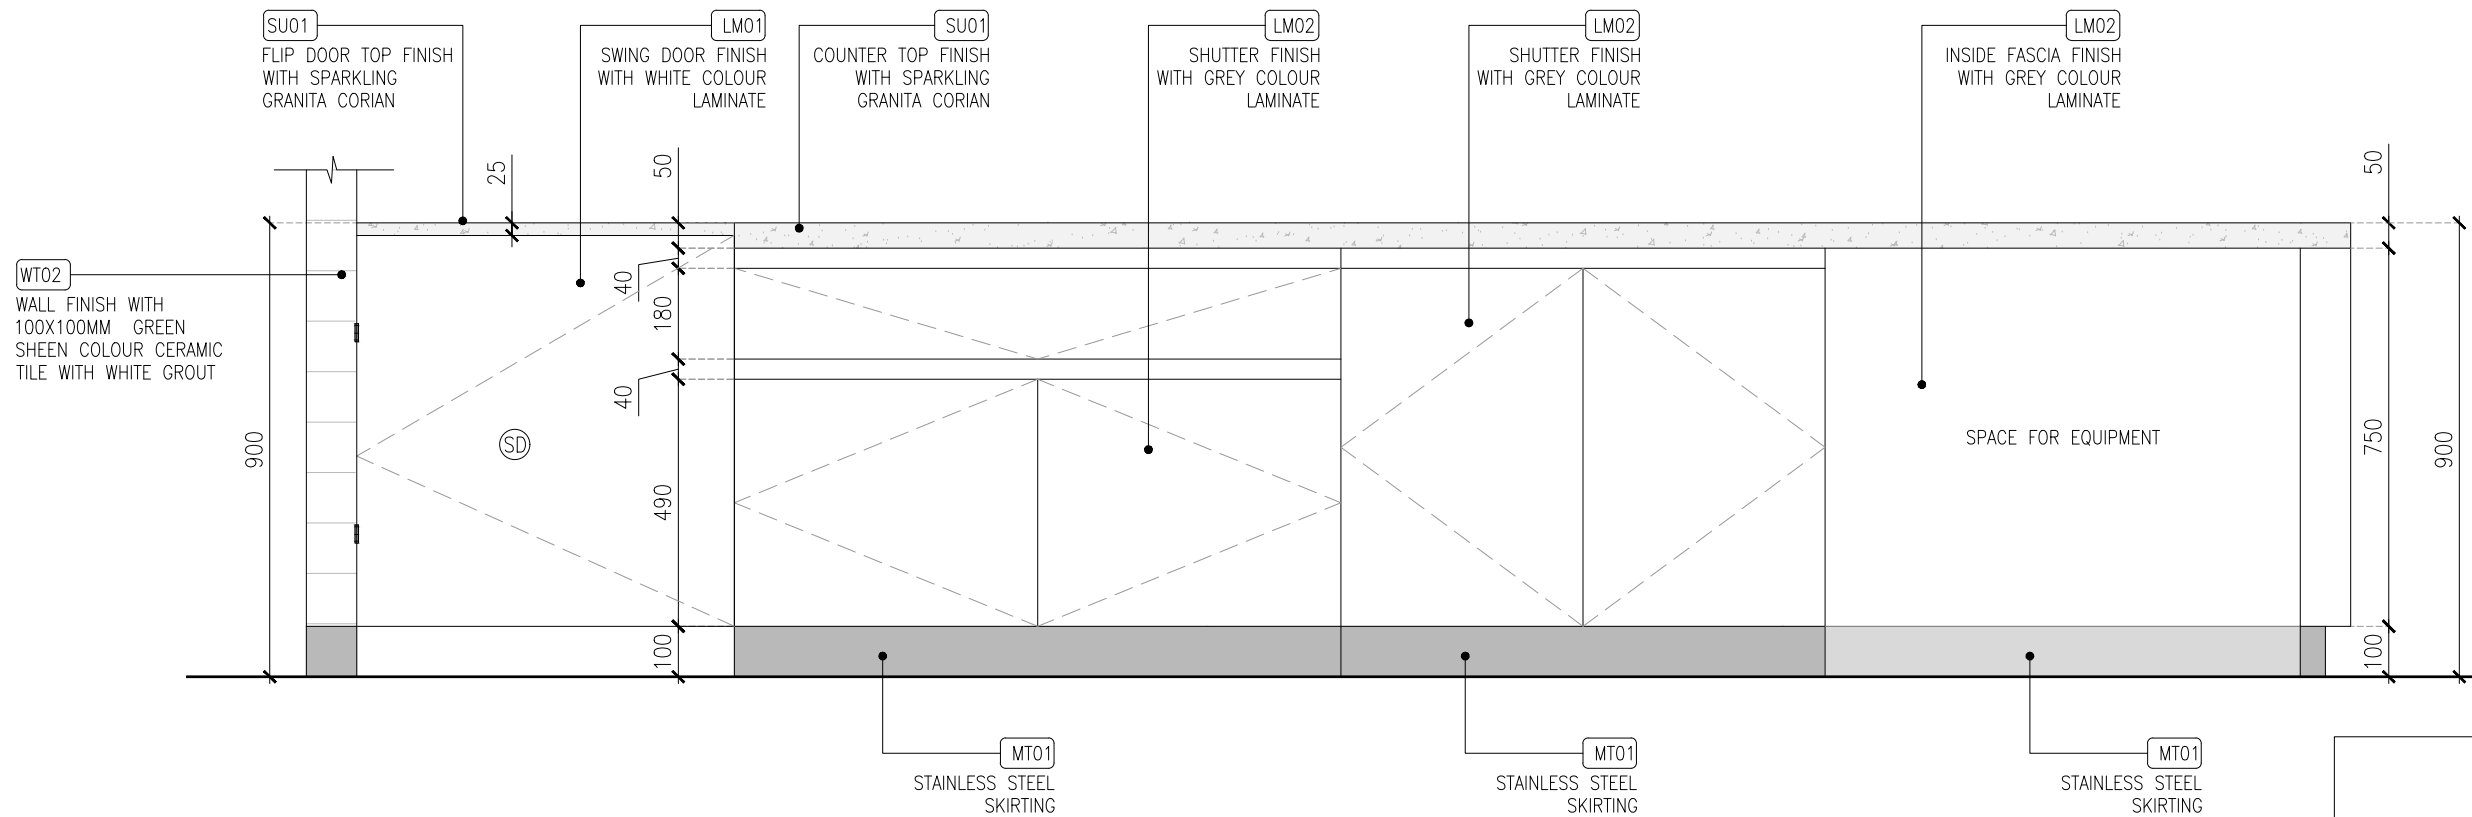

REV DATE	DESCRIPTION	HOD NM	DRN CHK
C01 19.02.24	GOOD FOR CONSTRUCTION		








PROJECT  
FF-045  
MILIE COOKIES  
HYDERABAD AIRPORT

DRAWING TITLE  
J01-FRONT COUNTER DETAIL PART-B

SCALE AS MENTIONED DATE 19.02.2024 DRAWN HOD A3 SHEET

STATUS  
GOOD FOR CONSTRUCTION

ORG PROJECT NO DRAWING TYPE NUMBER REV  
TFS XXXX 04DE 401 C01

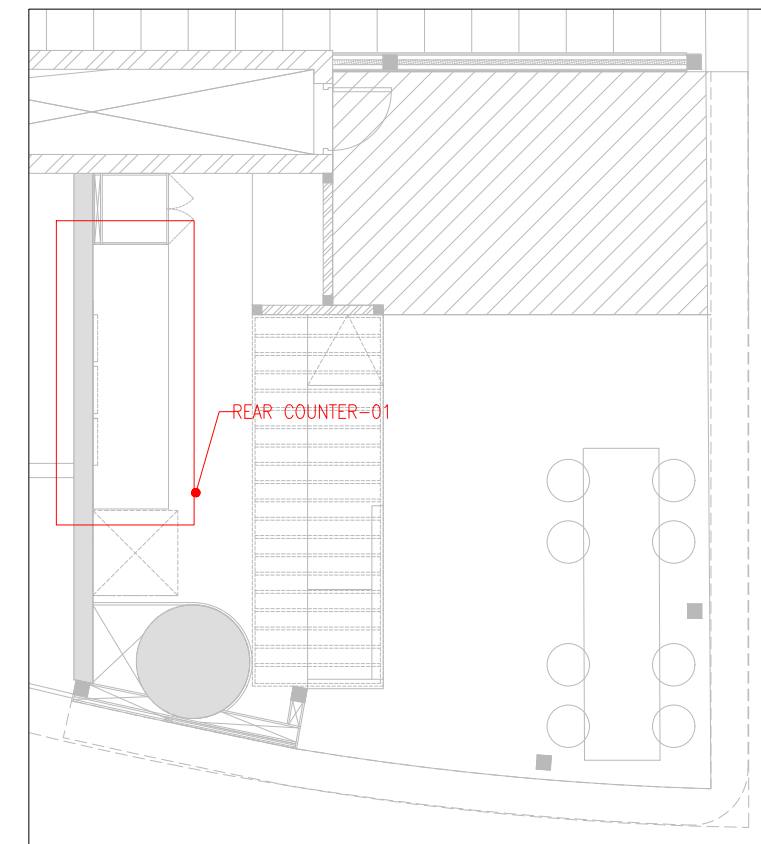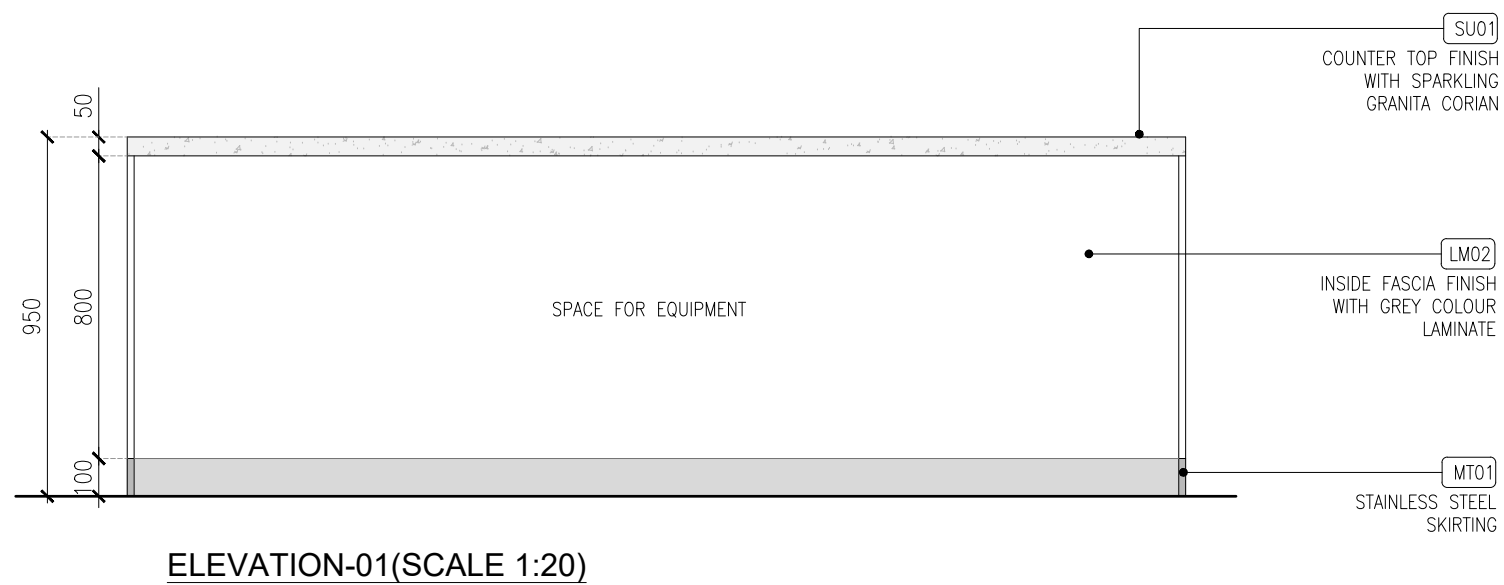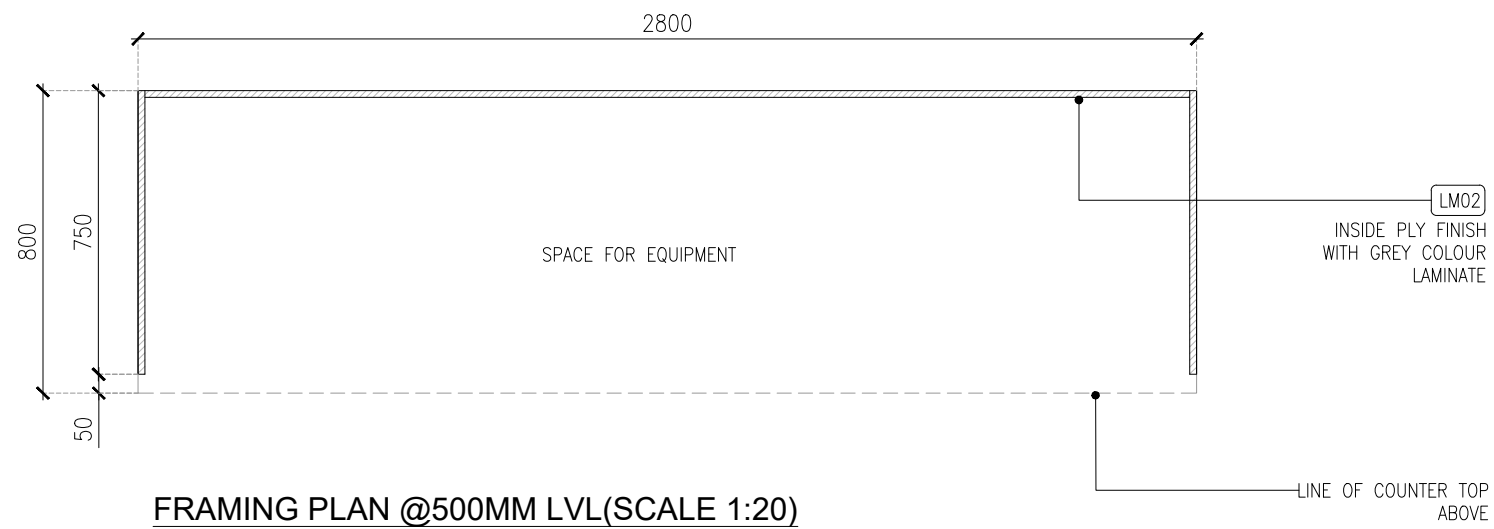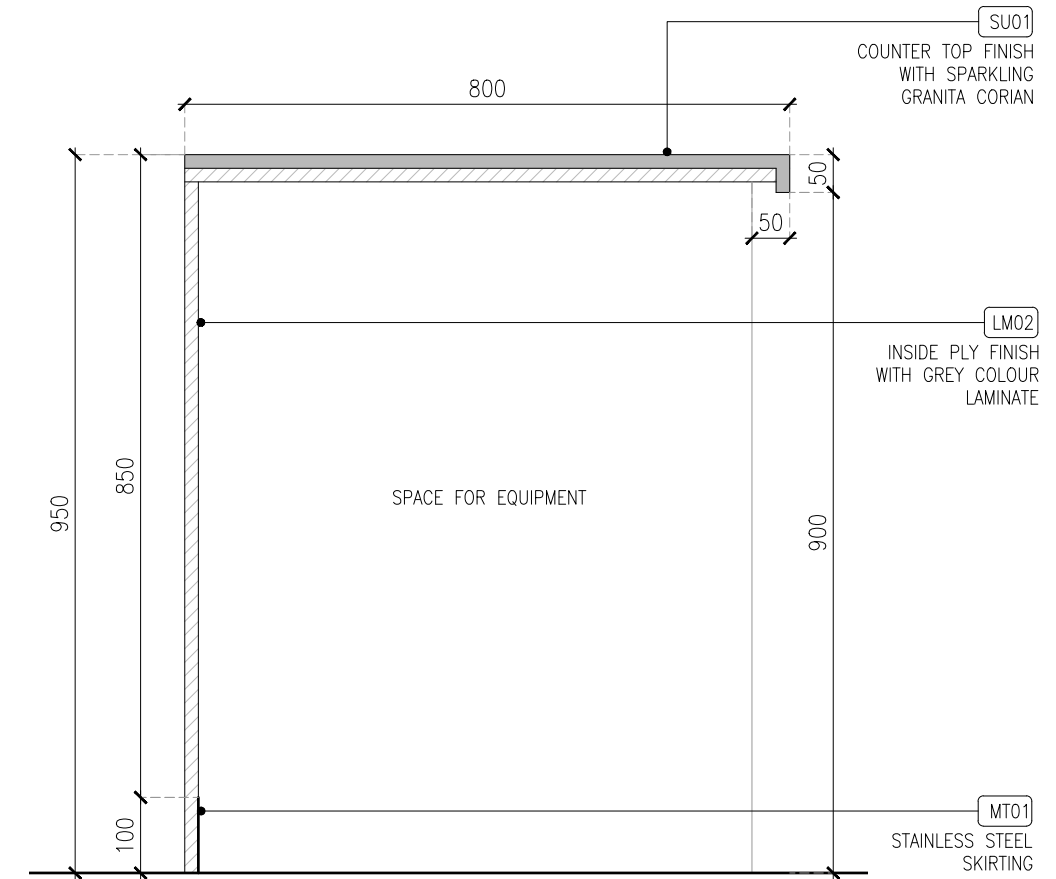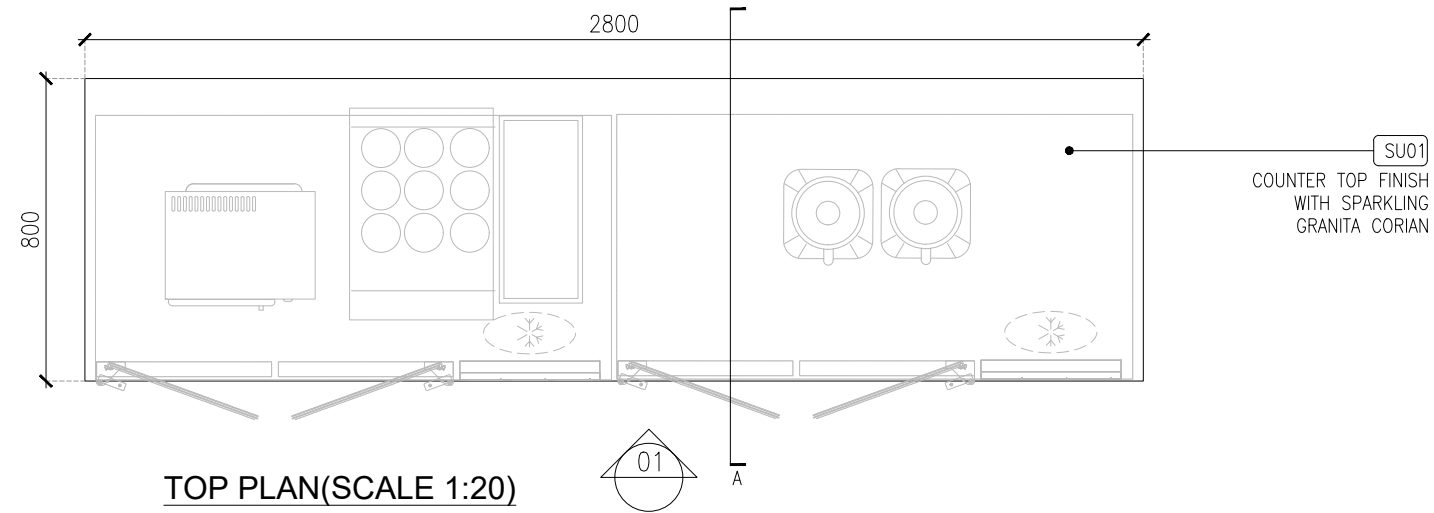

REV	DATE	DESCRIPTION	HOD	NM
C01	19.02.24	GOOD FOR CONSTRUCTION		



PROJECT  
**FF-045**  
**MILIE COOKIES**  
**HYDERABAD AIRPORT**


DRAWING TITLE  
**J02-REAR COUNTER-01 DETAIL**

SCALE AS MENTIONED DATE 19.02.2024 DRAWN HOD A3 SHEET


STATUS  
**GOOD FOR CONSTRUCTION**

ORG	PROJECT NO	DRAWING TYPE	NUMBER	REV
TFS	XXXX	04DE	402	C01


01  
04DE-402  
**J02-REAR COUNTER-01 DETAIL**

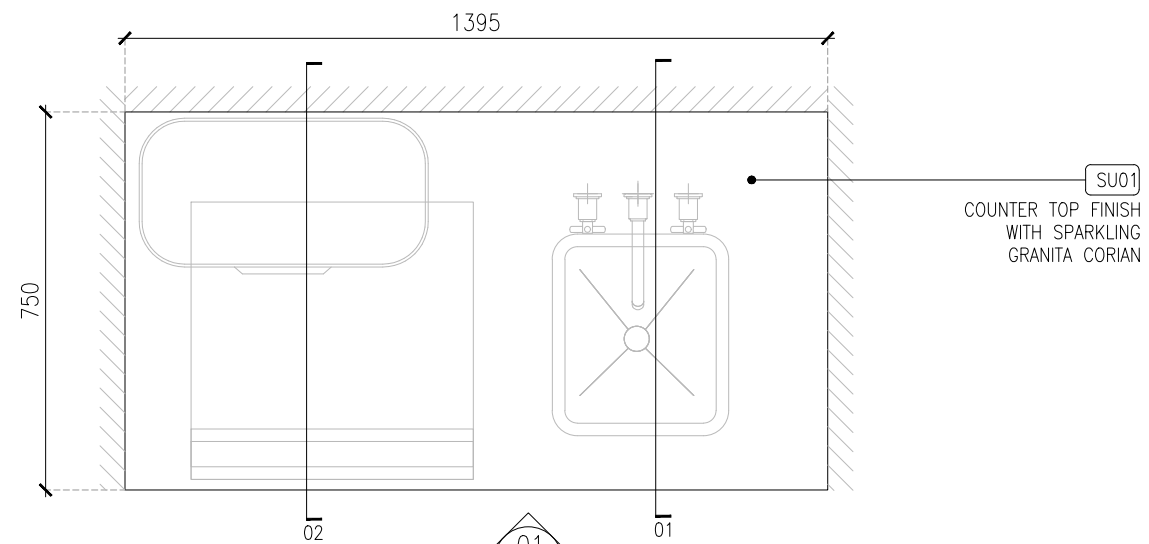


TOP PLAN (SCALE 1:15)

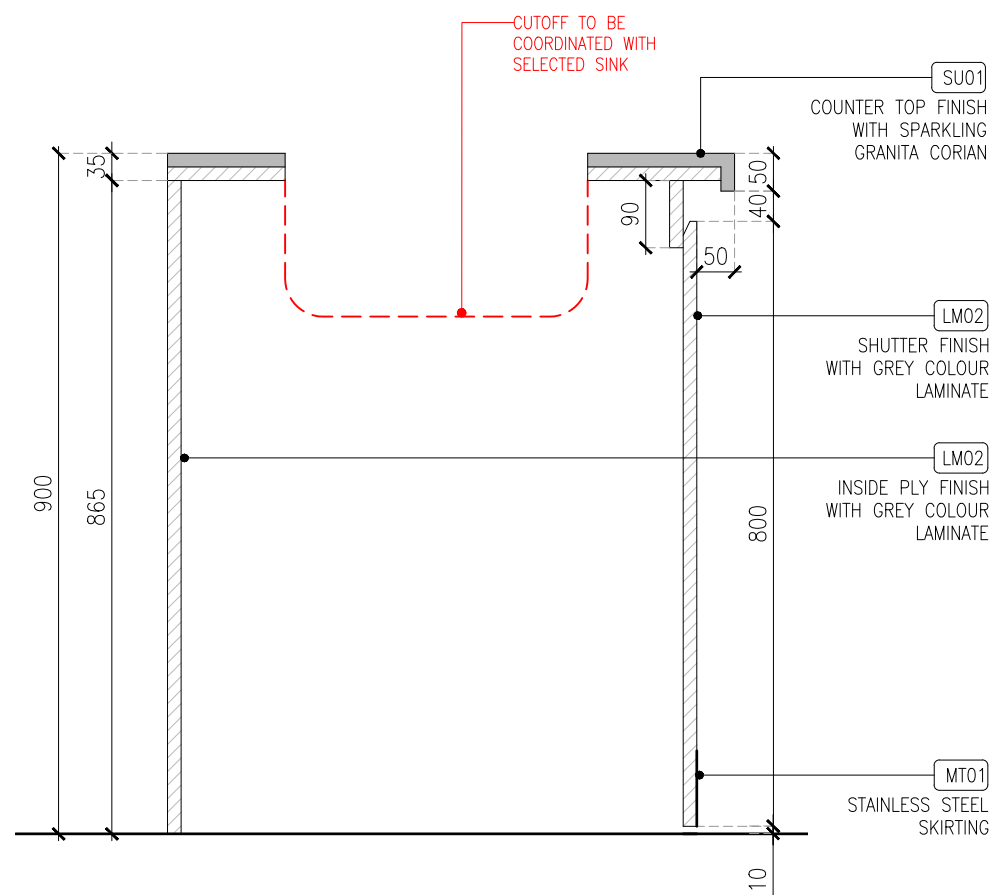


SECTION-01 (SCALE 1:10)

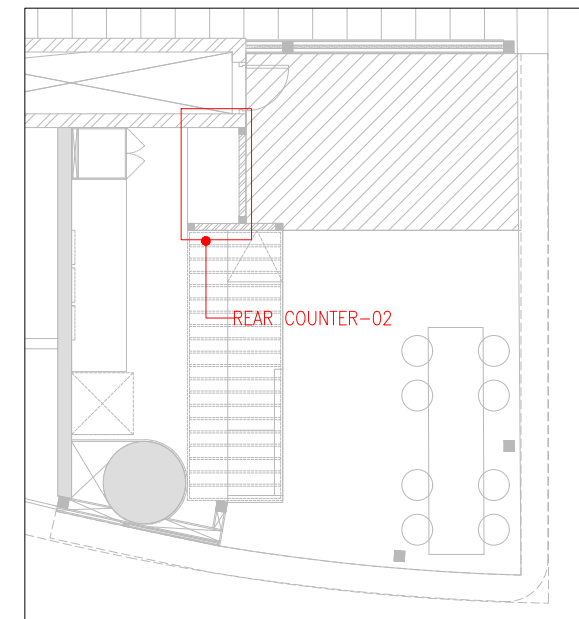


KEY PLAN

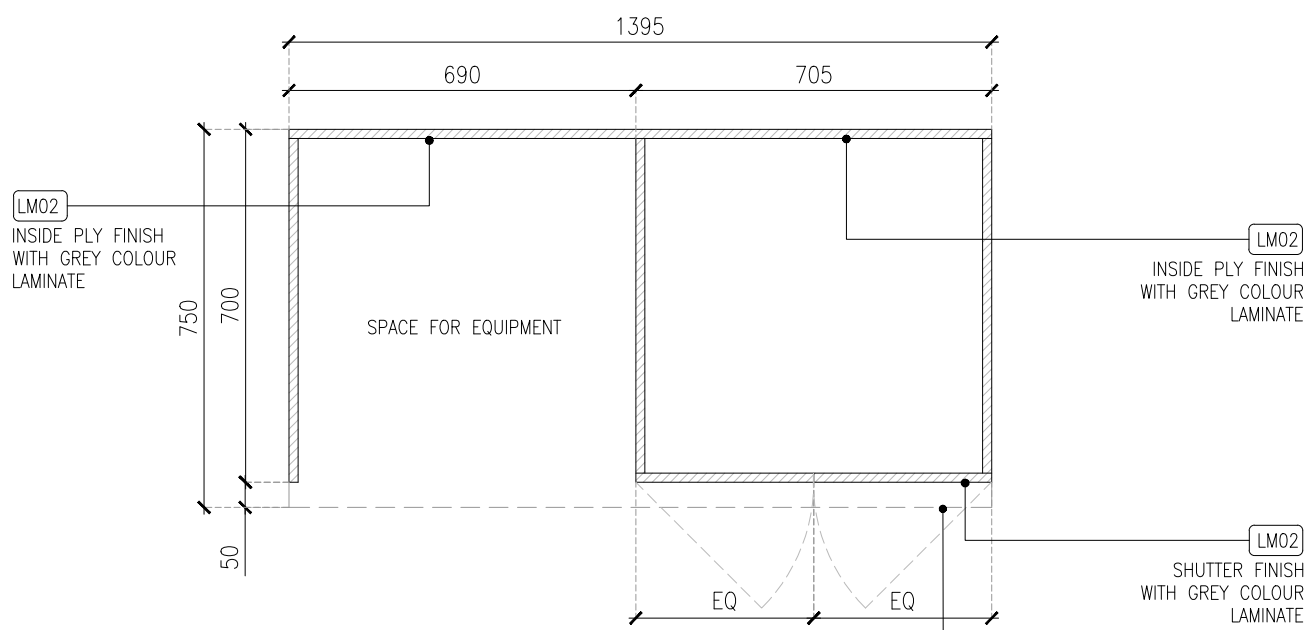

FRAMING PLAN @500MM LVL (SCALE 1:15)

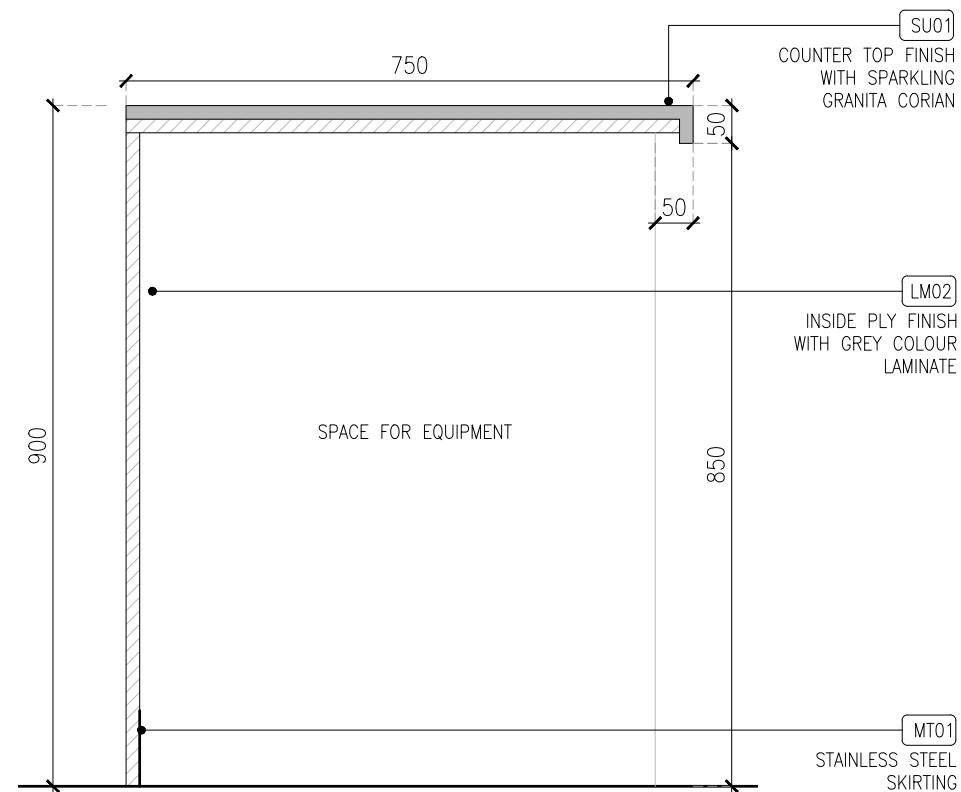

SECTION-01 (SCALE 1:10)

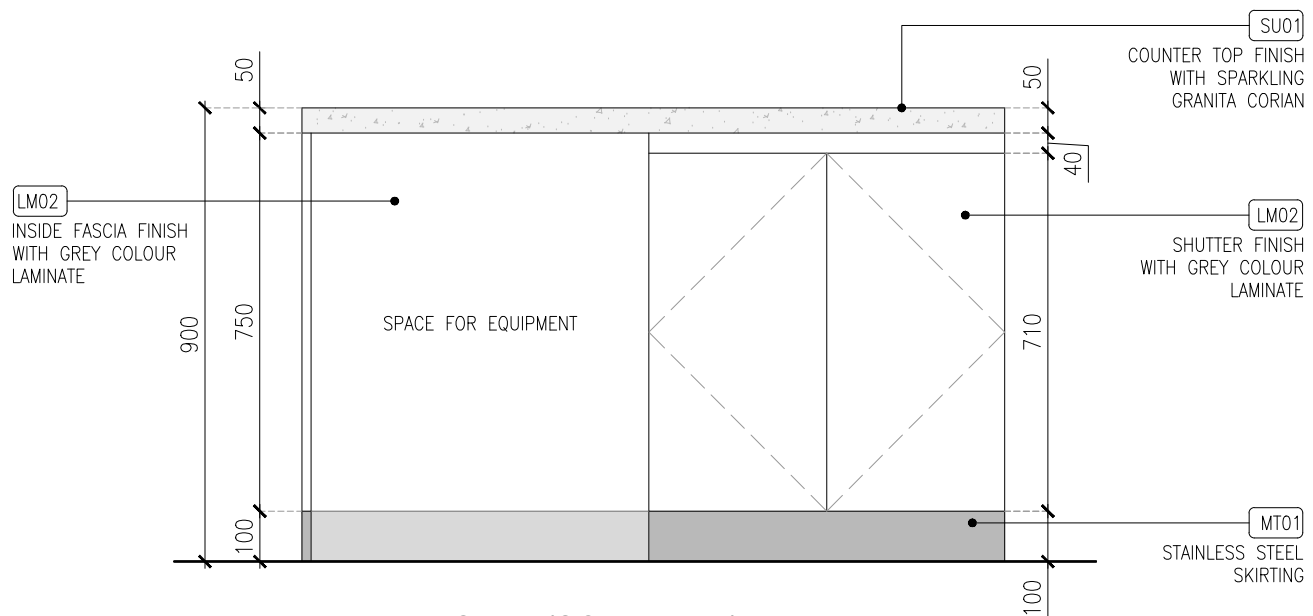

ELEVATION-01 (SCALE 1:15)

REV	DATE	DESCRIPTION	HOD	NM	DRN	CHK
C01	19.02.24	GOOD FOR CONSTRUCTION				



PROJECT  
**FF-045**  
**MILIE COOKIES**  
**HYDERABAD AIRPORT**


DRAWING TITLE  
**J03-REAR COUNTER-01 DETAIL**

SCALE AS MENTIONED DATE 19.02.2024 DRAWN HOD A3 SHEET


STATUS  
**GOOD FOR CONSTRUCTION**

ORG	PROJECT NO	DRAWING TYPE	NUMBER	REV
TFS	XXXX	04DE	403	C01


**01** J03-REAR COUNTER-02 DETAIL  
04DE-403

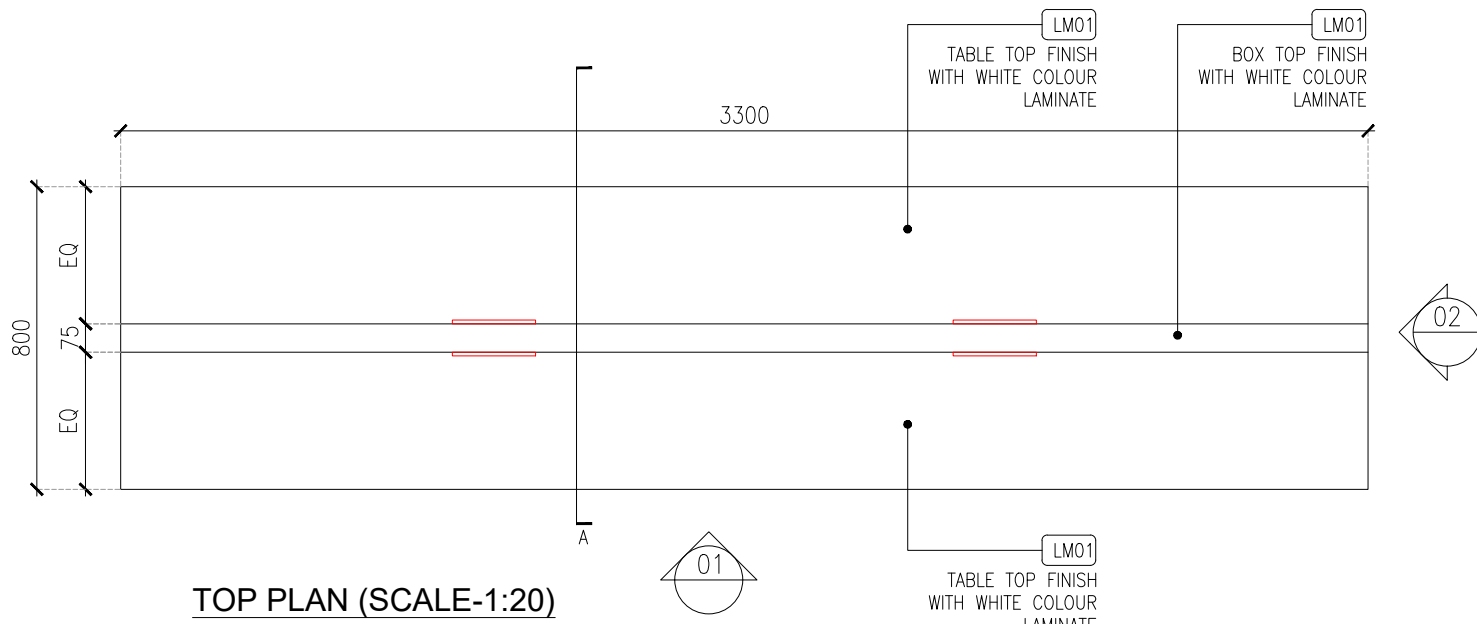


TOP PLAN (SCALE-1:20)

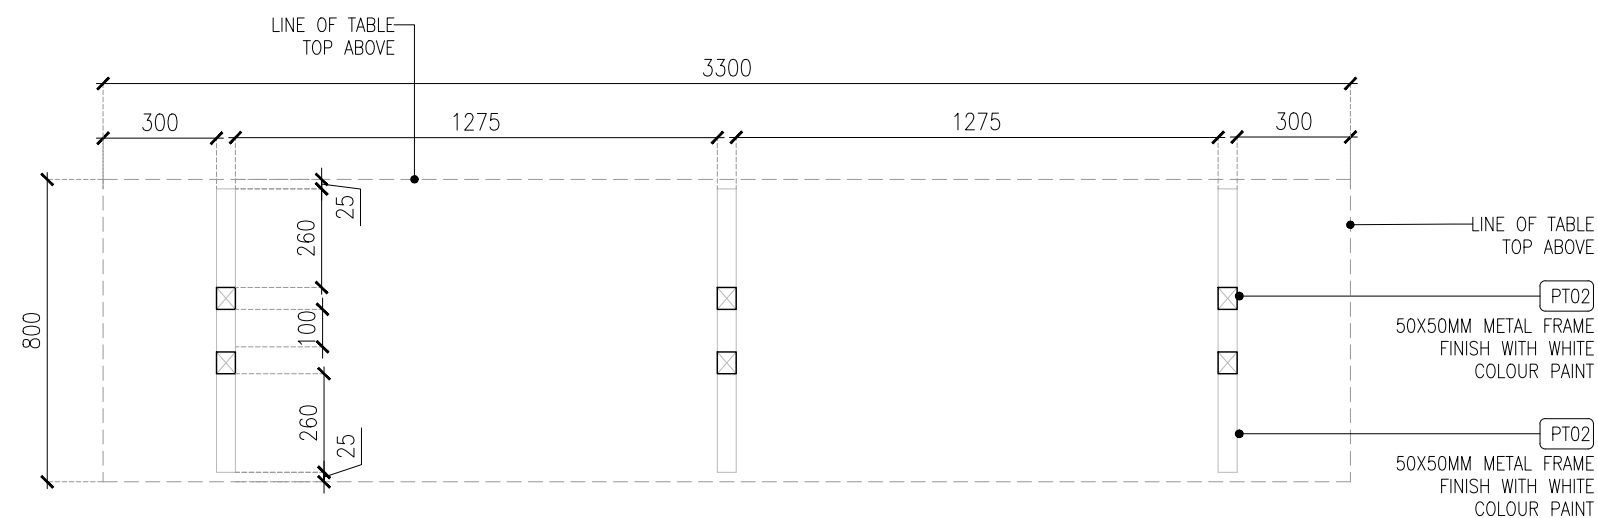


FRAMING PLAN @750MM LVL (SCALE-1:20)

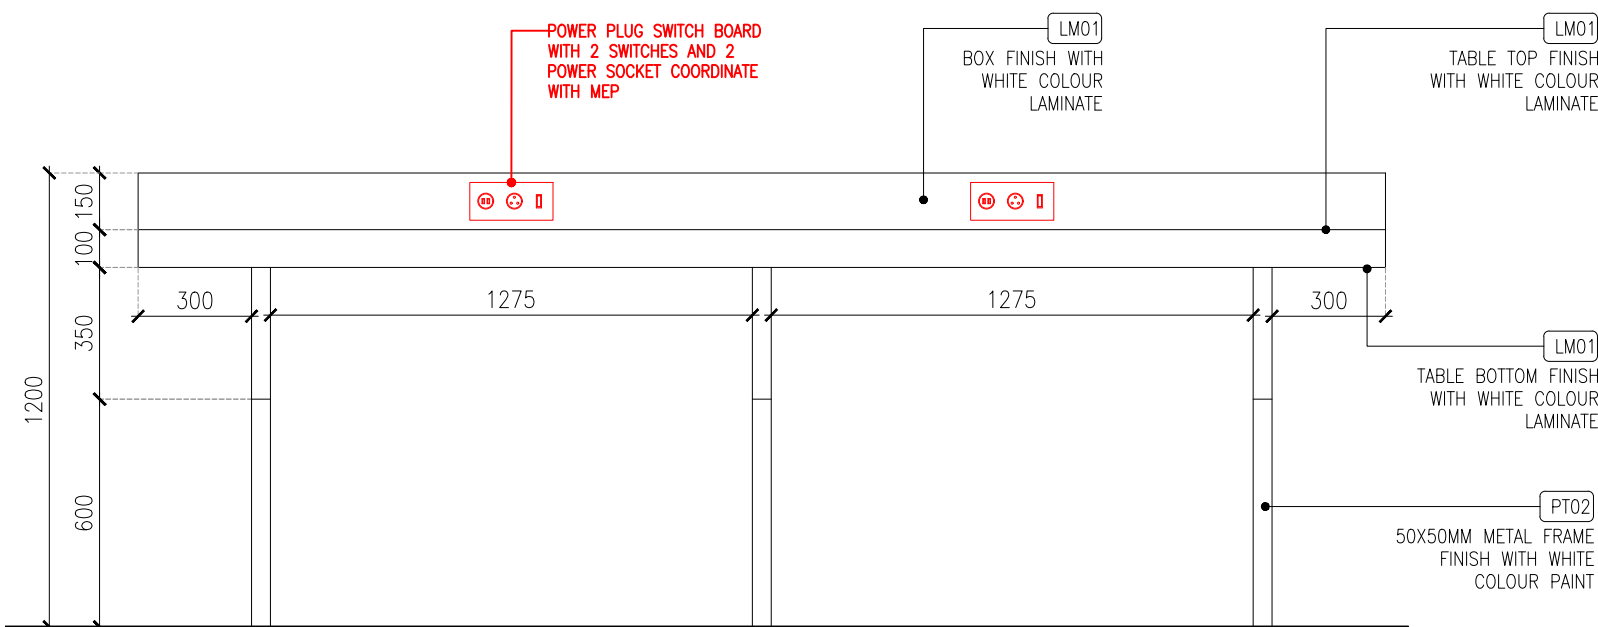


ELEVATION-01 (SCALE-1:20)

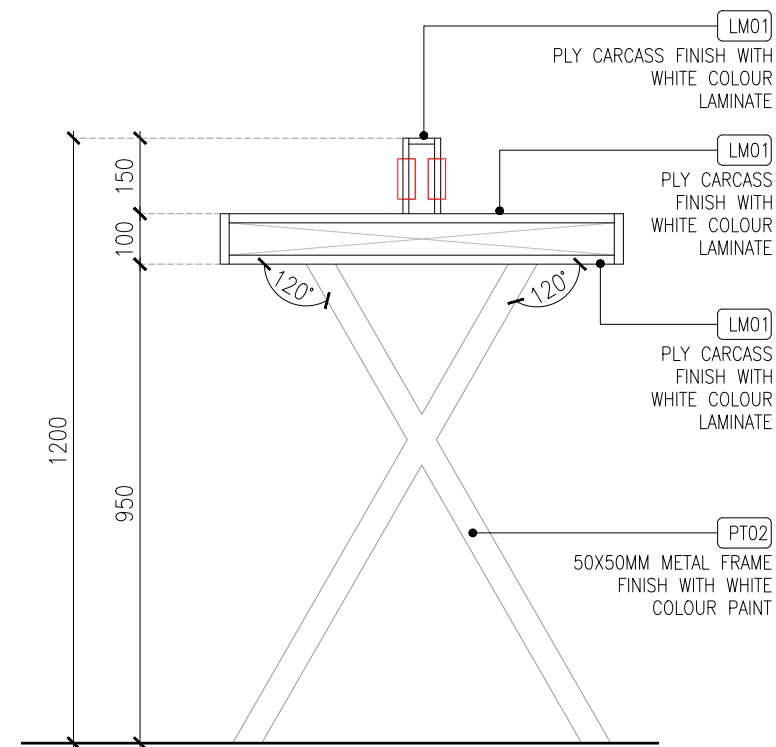

SECTION-A (SCALE-1:15)

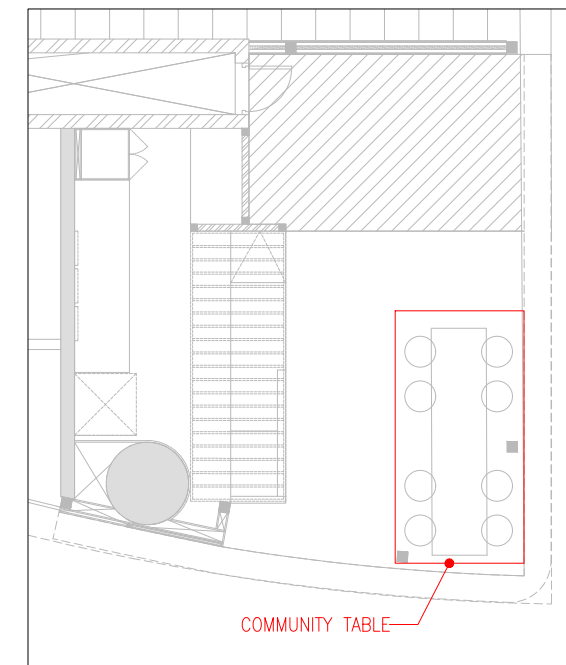

KEYPLAN

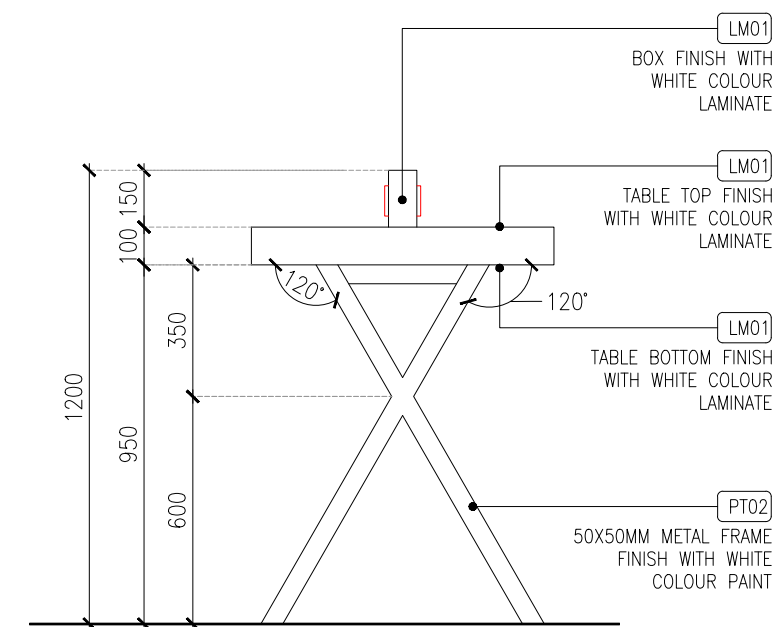

ELEVATION-02 (SCALE-1:20)

REV	DATE	DESCRIPTION	HOD	NM
C01	19.02.24	GOOD FOR CONSTRUCTION		
			DRN	CHK



PROJECT  
**FF-045**  
**MILIE COOKIES**  
**HYDERABAD AIRPORT**

DRAWING TITLE  
**J04-COMMUNITY TABLE DETAIL**


SCALE AS MENTIONED DATE 19.02.2024 DRAWN HOD A3 SHEET

STATUS  
**GOOD FOR CONSTRUCTION**


ORG	PROJECT NO	DRAWING TYPE	NUMBER	REV
TFS	XXXX	04DE	404	C01

01 J04-COMMUNITY TABLE DETAIL  
04DE-404




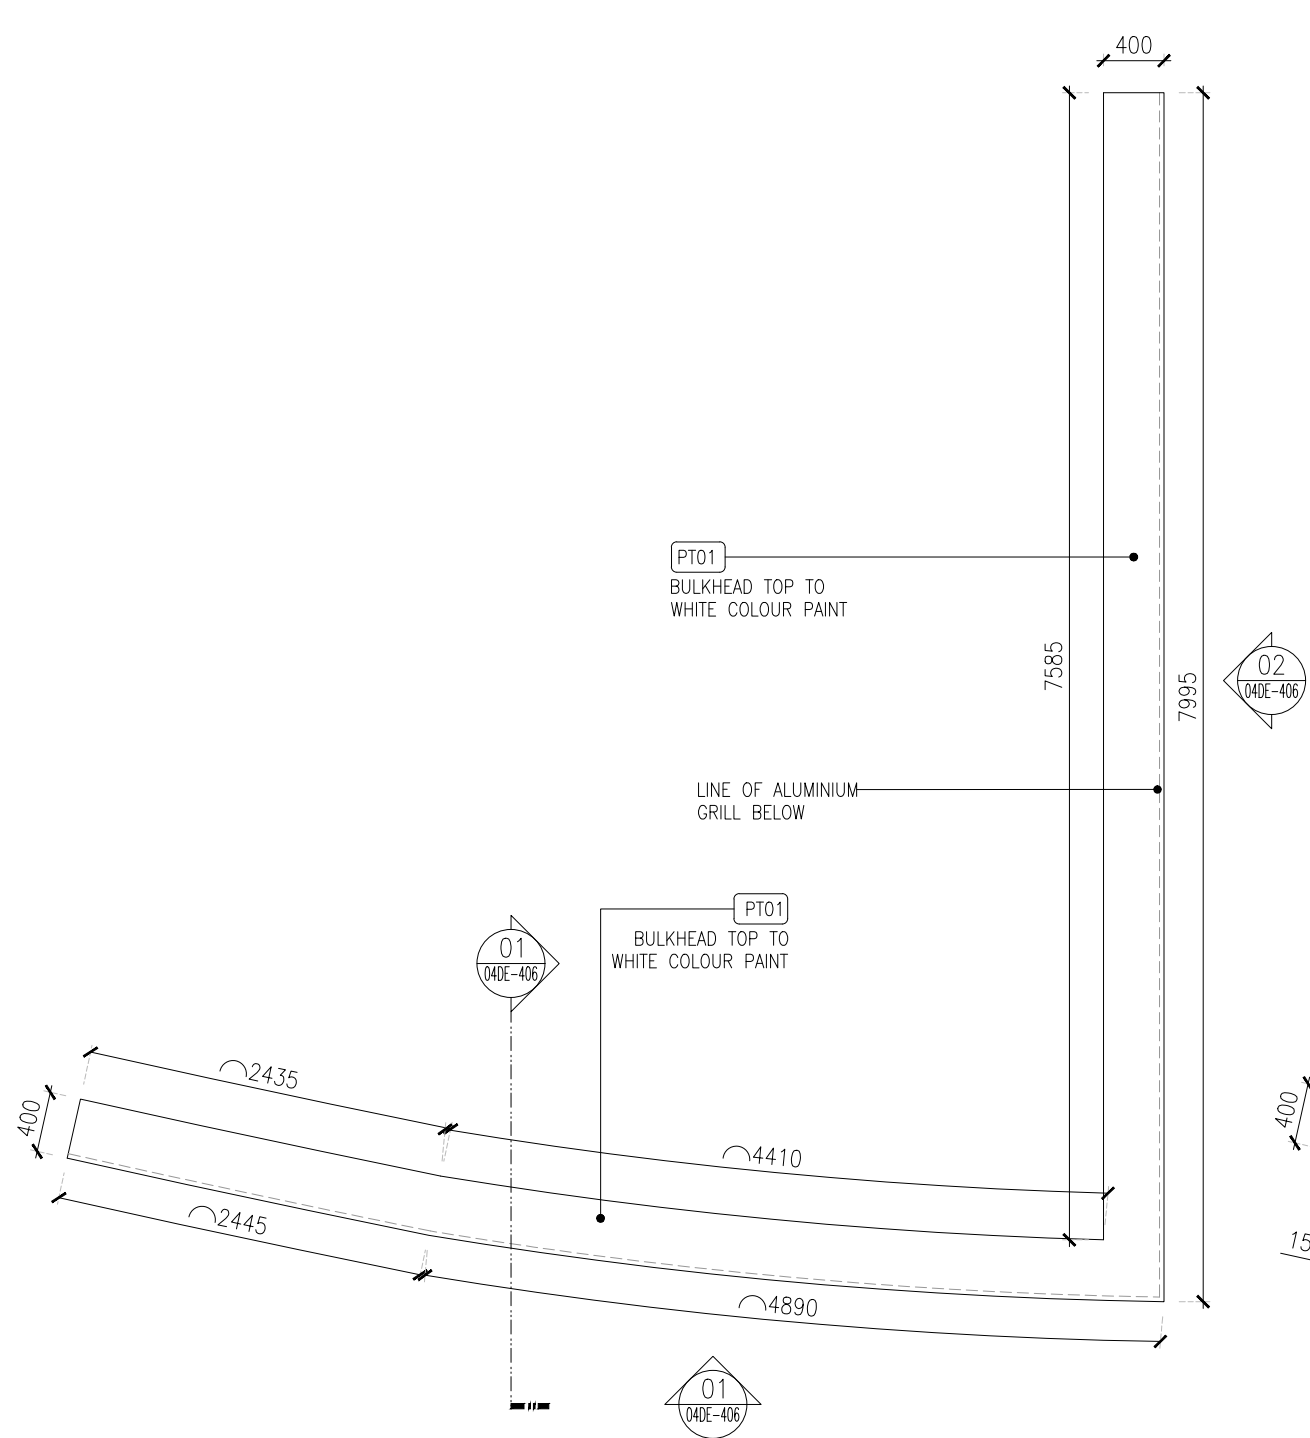

TOP PLAN

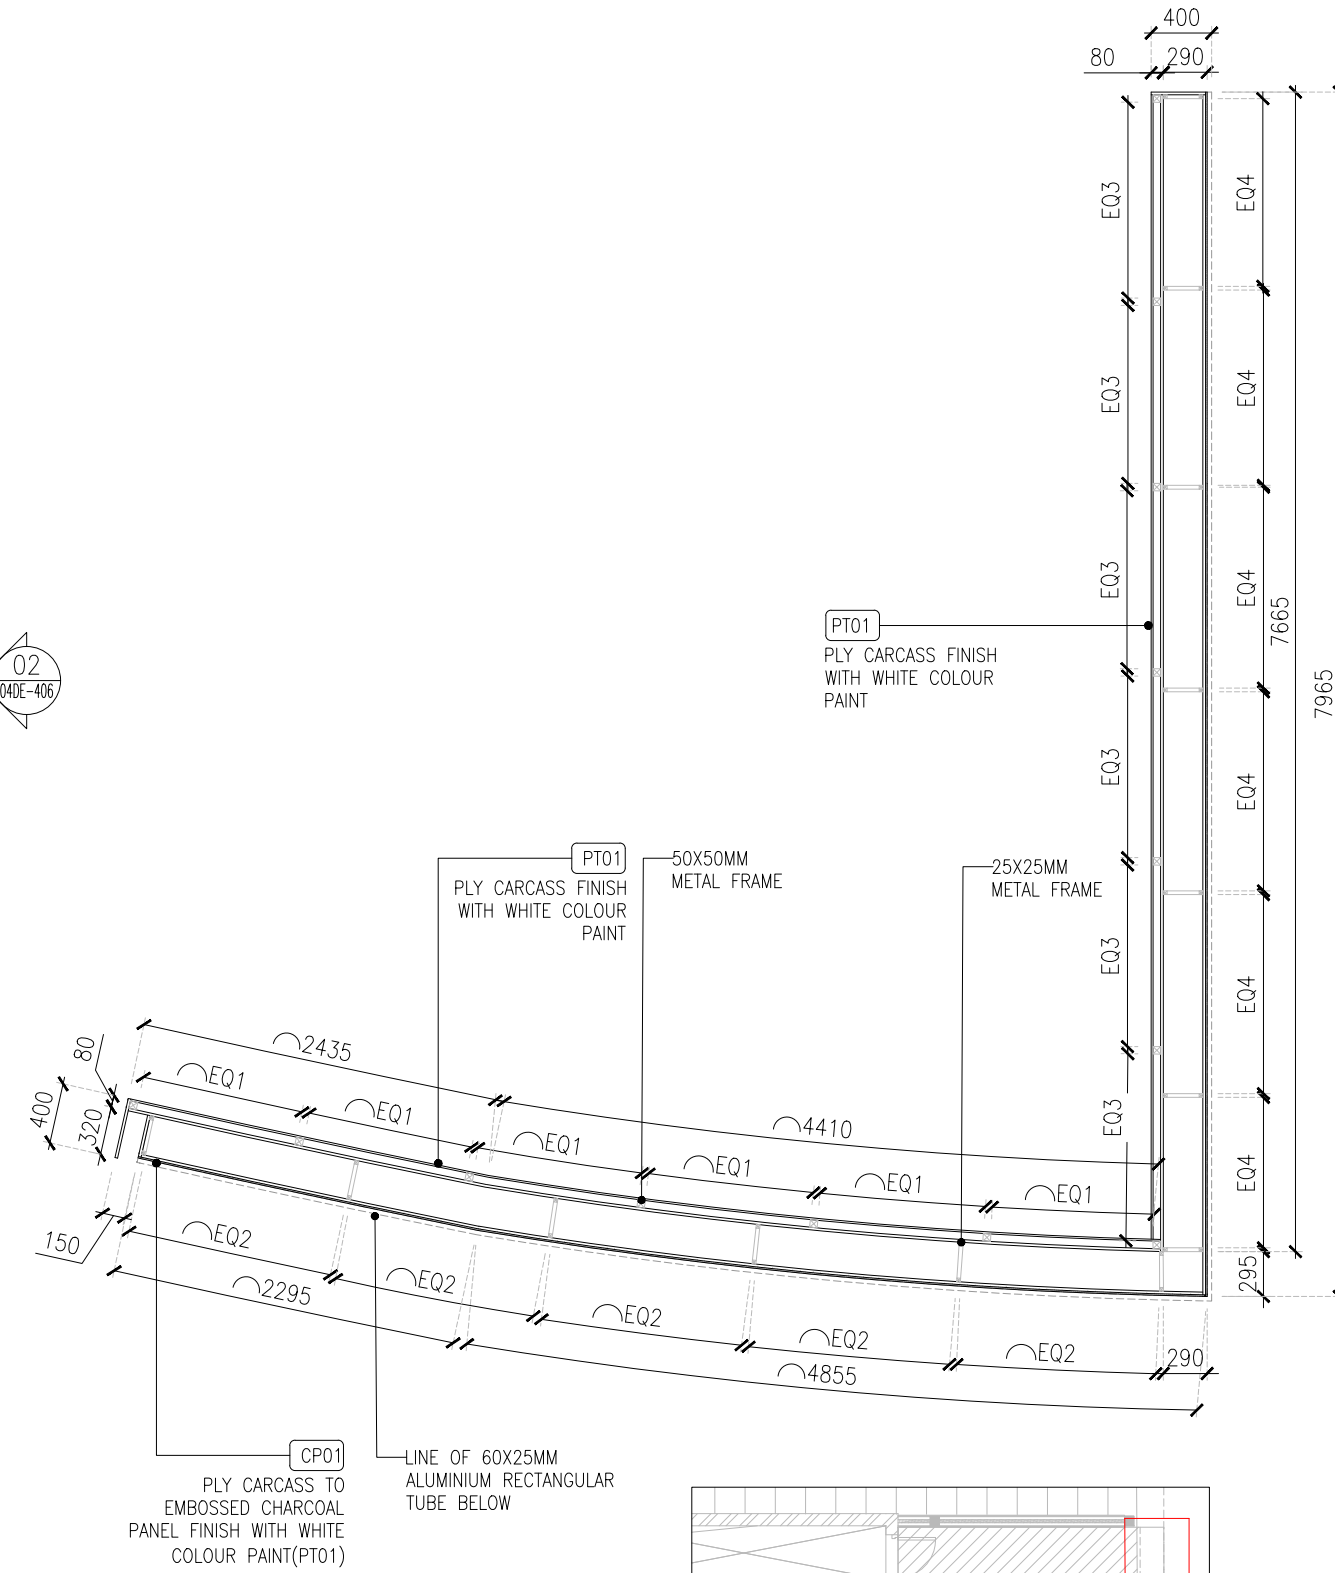

FRAMING PLAN @ 500MM LVL

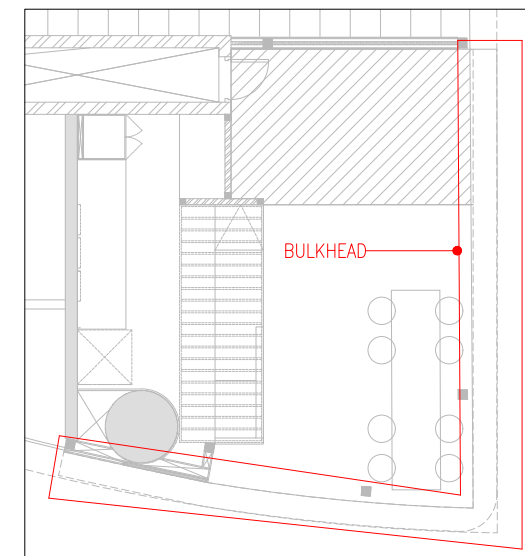

KEY PLAN

01 04DE-405 1:40 J05 - BULKHEAD DETAIL-PART:A

C01	19.02.24	GOOD FOR CONSTRUCTION	HOD	NM
REV	DATE	DESCRIPTION	DRN	CHK







PROJECT  
FF-045  
MILIE COOKIES  
HYDERABAD AIRPORT

DRAWING TITLE  
J05 - BULKHEAD DETAIL - PART:A


SCALE 1:40 DATE 19.02.2024 DRAWN HOD A3 SHEET

STATUS  
GOOD FOR CONSTRUCTION


ORG	PROJECT NO	DRAWING TYPE	NUMBER	REV
TFS	XXXX	04DE	405	C01

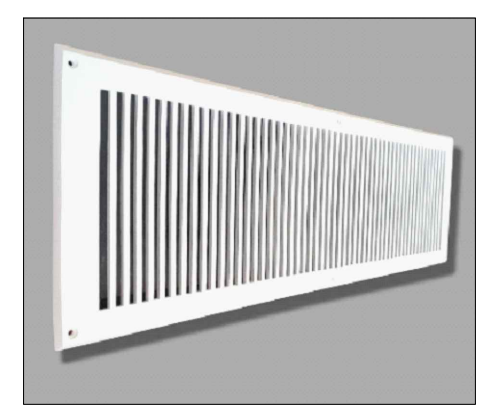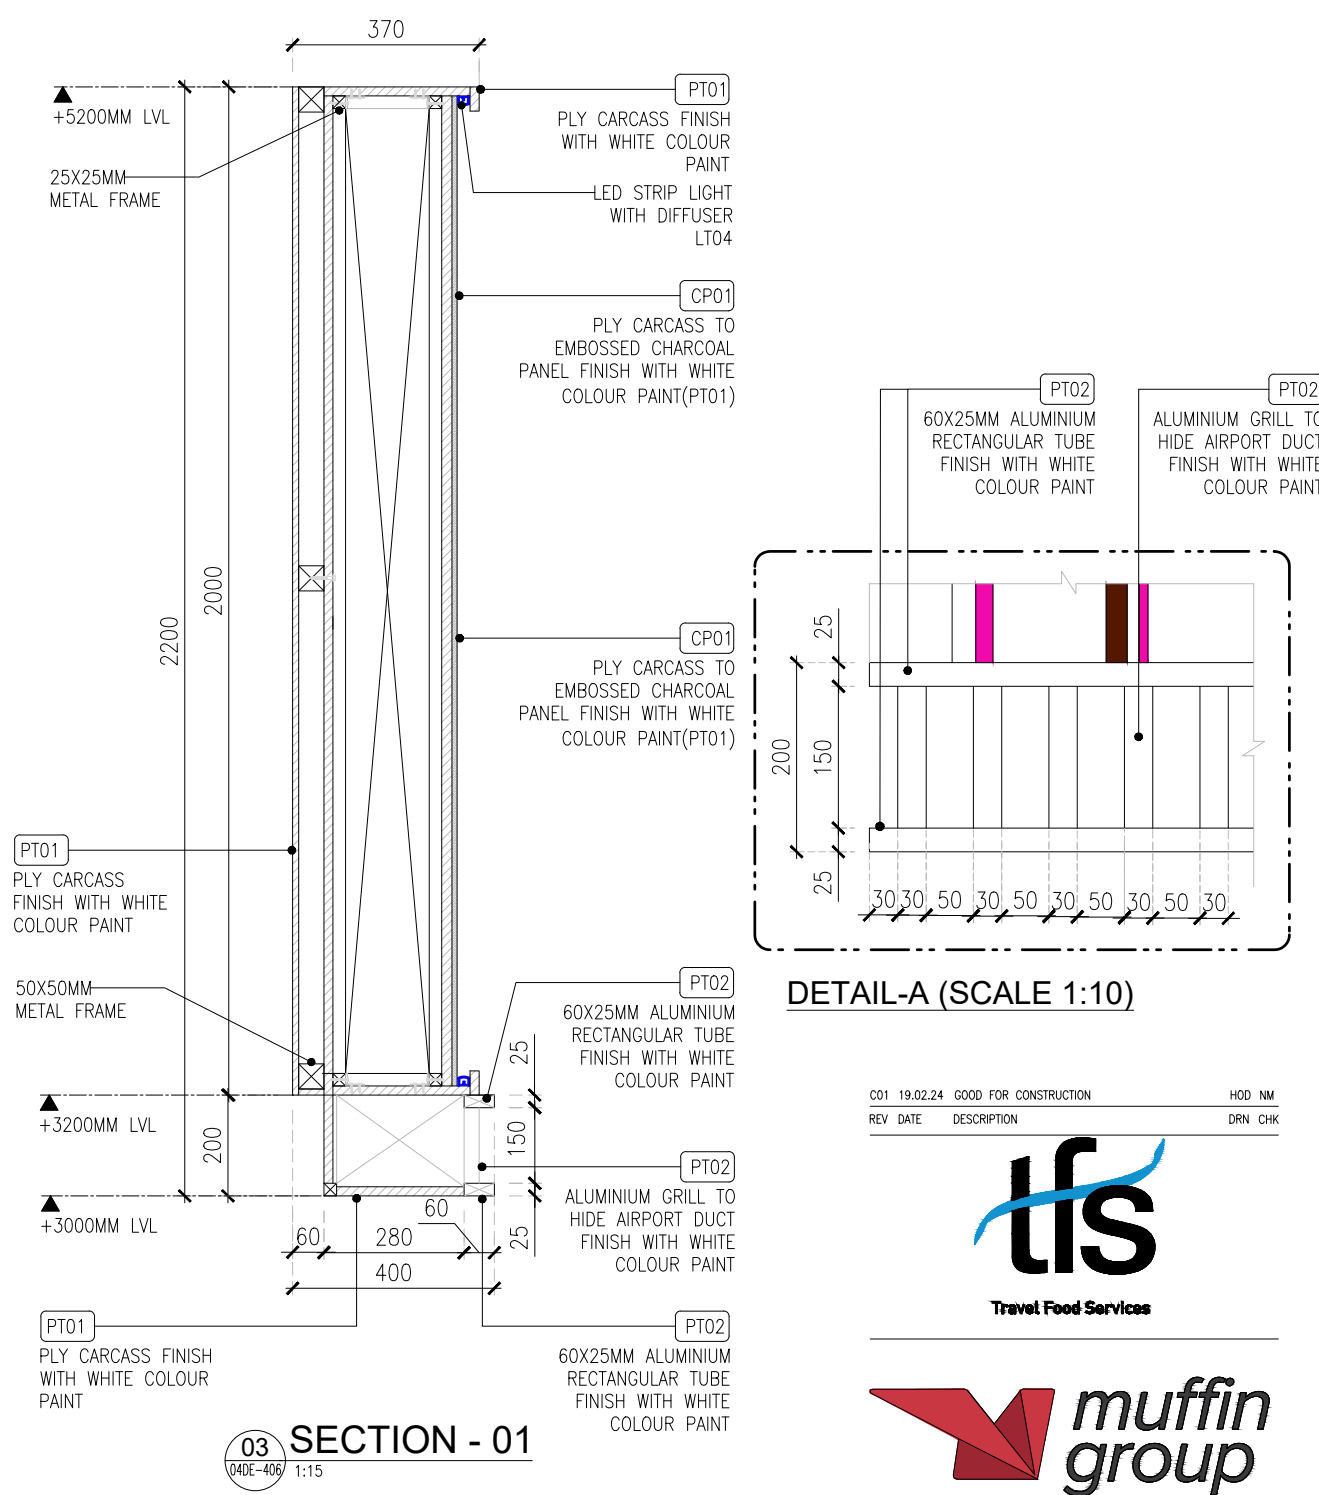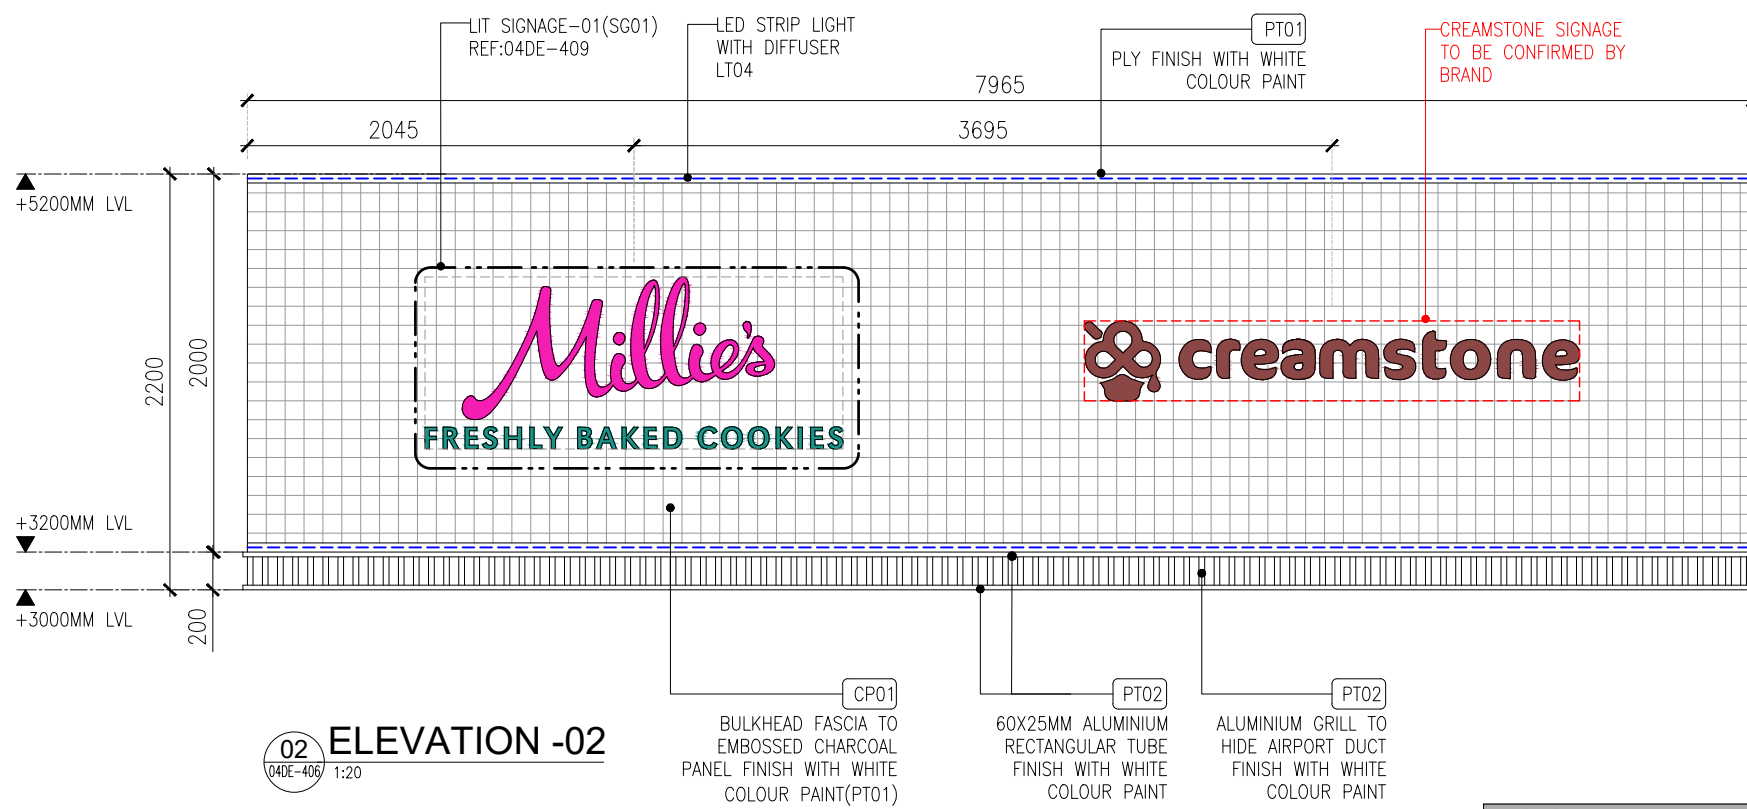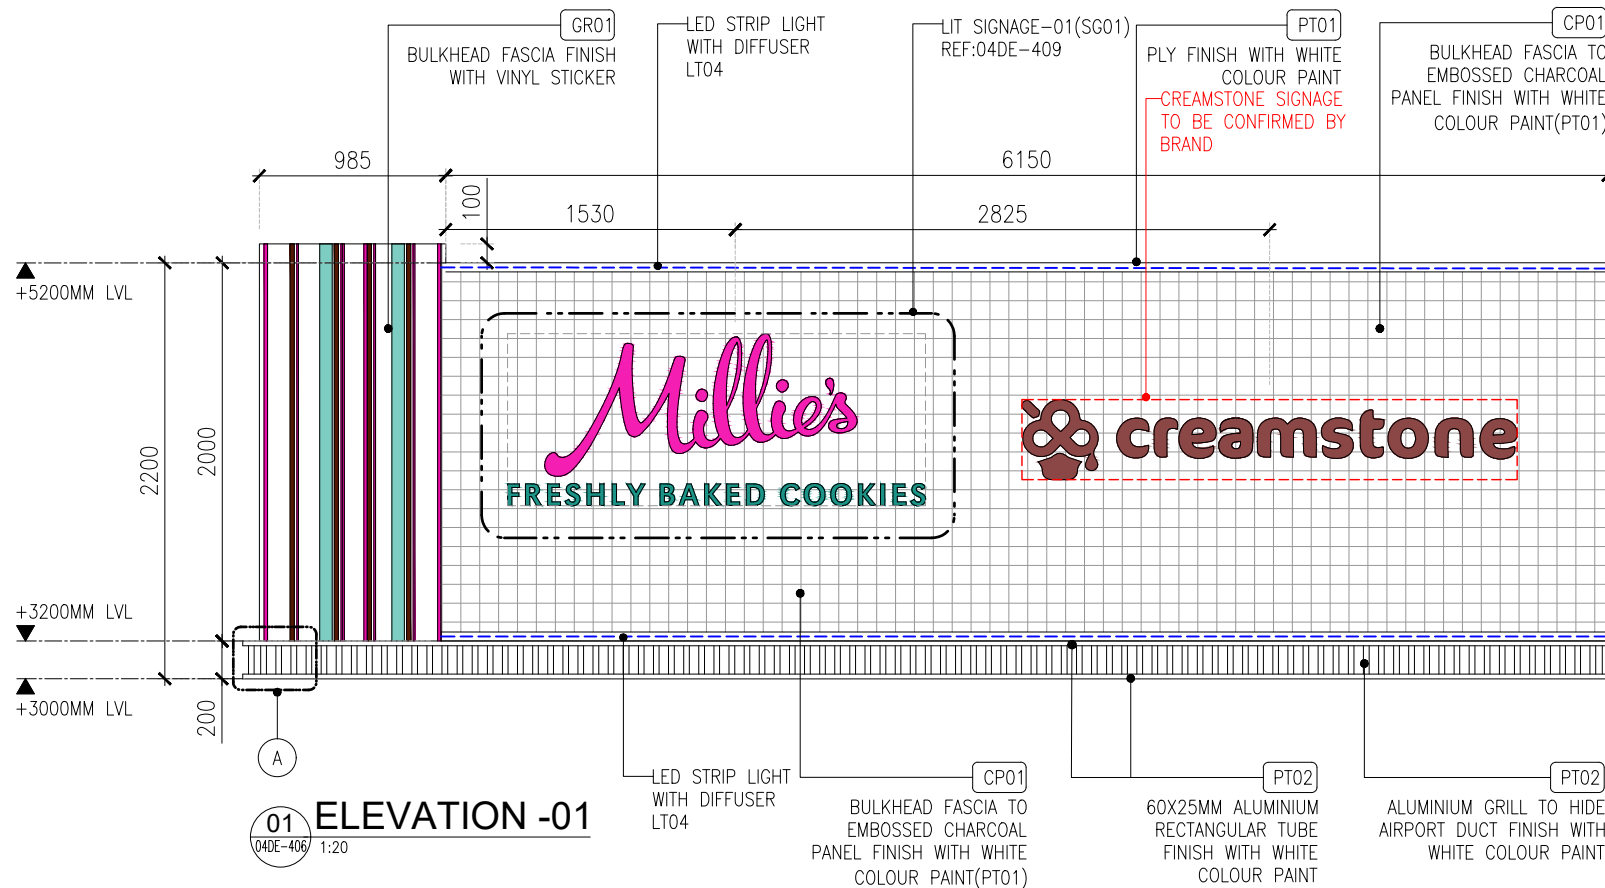

REF IMG:ALUMINIUM GRILL

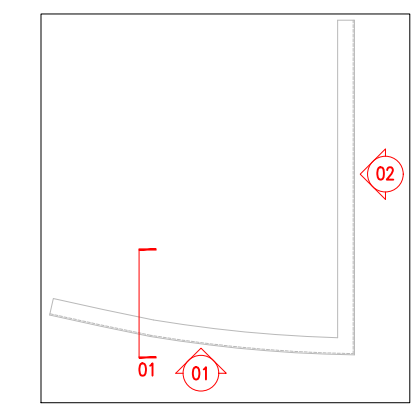

KEY PLAN

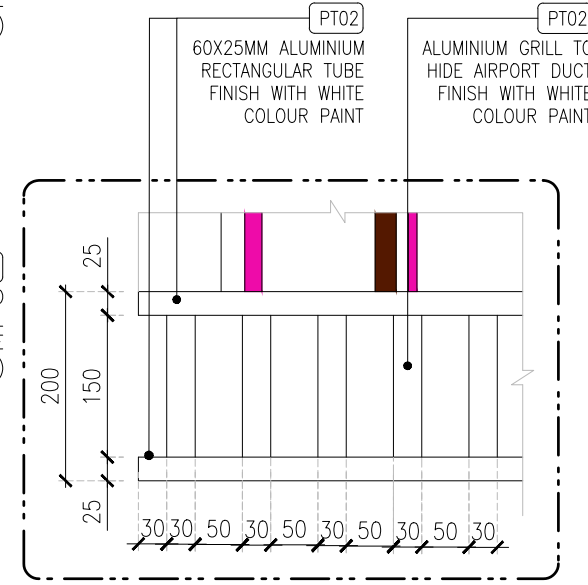

REV	DATE	DESCRIPTION	HOD	NM	DRN	CHK
C01	19.02.24	GOOD FOR CONSTRUCTION				







PROJECT  
**FF-045**  
**MILIE COOKIES**  
**HYDERABAD AIRPORT**

DRAWING TITLE  
**J05 - BULKHEAD DETAIL - PART:B**

SCALE AS MENTIONED DATE 19.02.2024 DRAWN HOD A3 SHEET

STATUS  
**GOOD FOR CONSTRUCTION**

ORG PROJECT NO DRAWING TYPE NUMBER REV  
**TFS XXXX 04DE 406 C01**

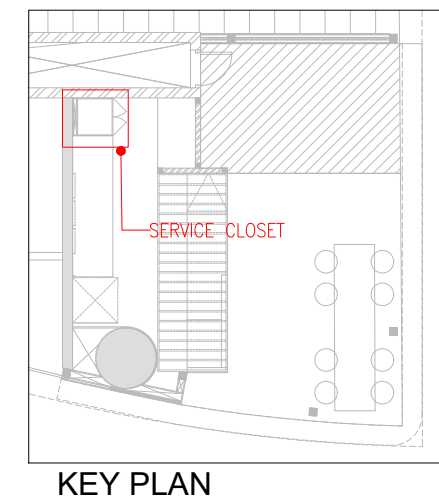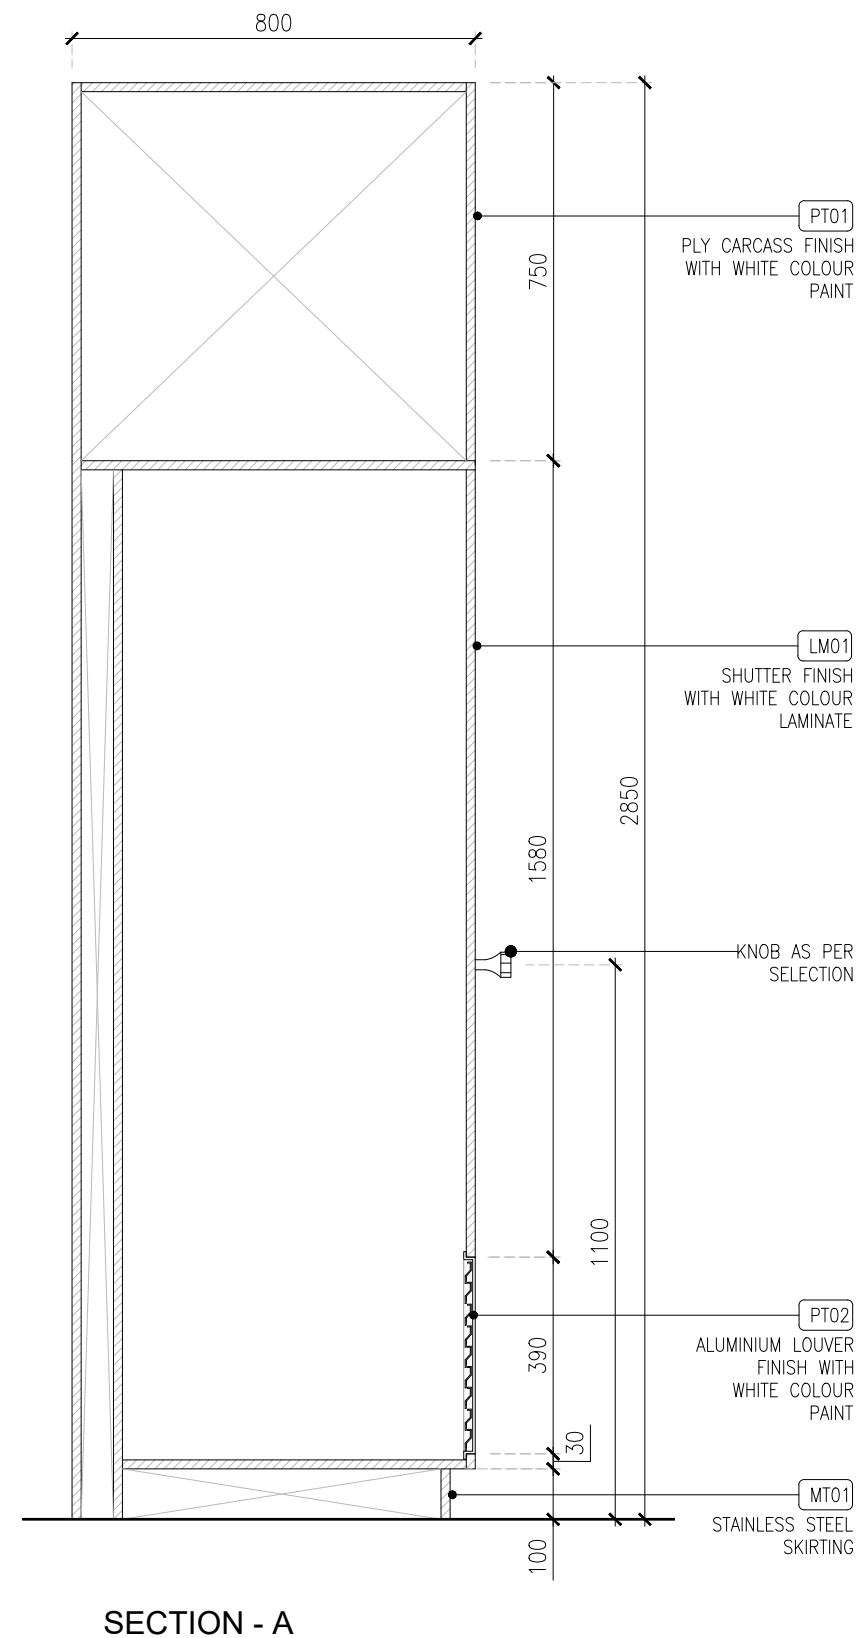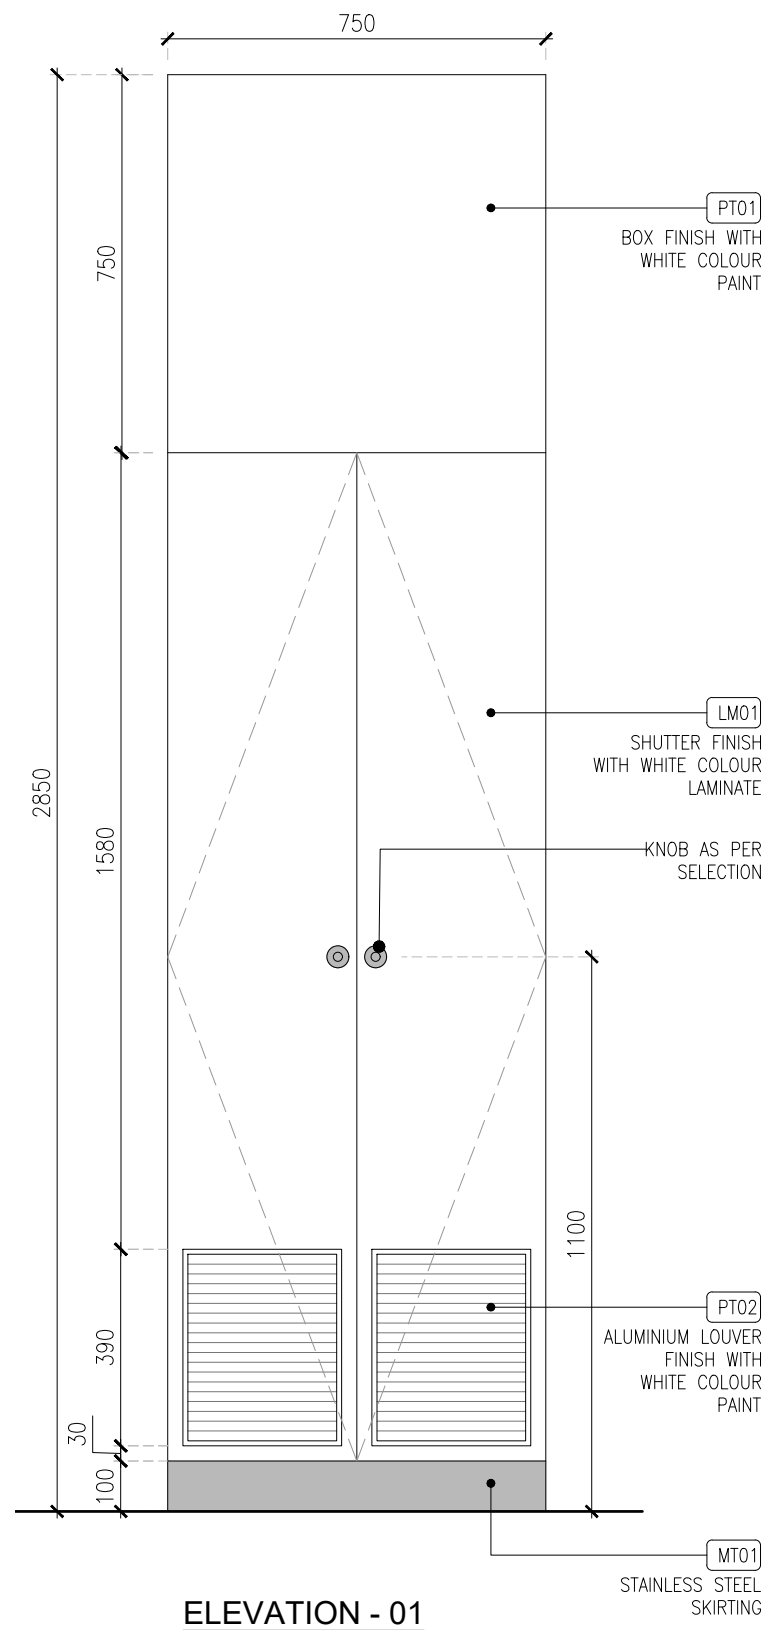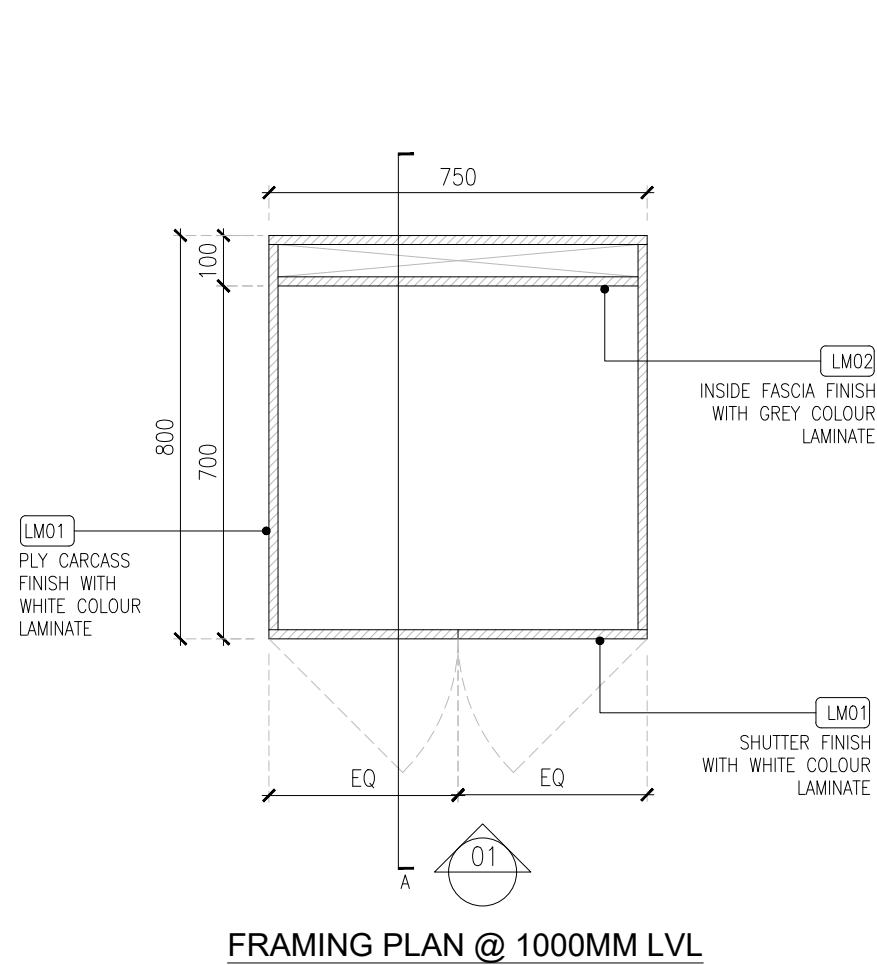

**01 J06 - SERVICE CLOSET DETAIL**  
04DE-407 1:15

REV DATE	DESCRIPTION	HOD NM	DRN CHK
C01 19.02.24	GOOD FOR CONSTRUCTION		




PROJECT  
**FF-045**  
**MILIE COOKIES**  
**HYDERABAD AIRPORT**

DRAWING TITLE  
**J06 - SERVICE CLOSET DETAIL**


SCALE 1:15 DATE 19.02.2024 DRAWN HOD A3 SHEET

STATUS  
**GOOD FOR CONSTRUCTION**


ORG	PROJECT NO	DRAWING TYPE	NUMBER	REV
TFS	XXXX	04DE	407	C01

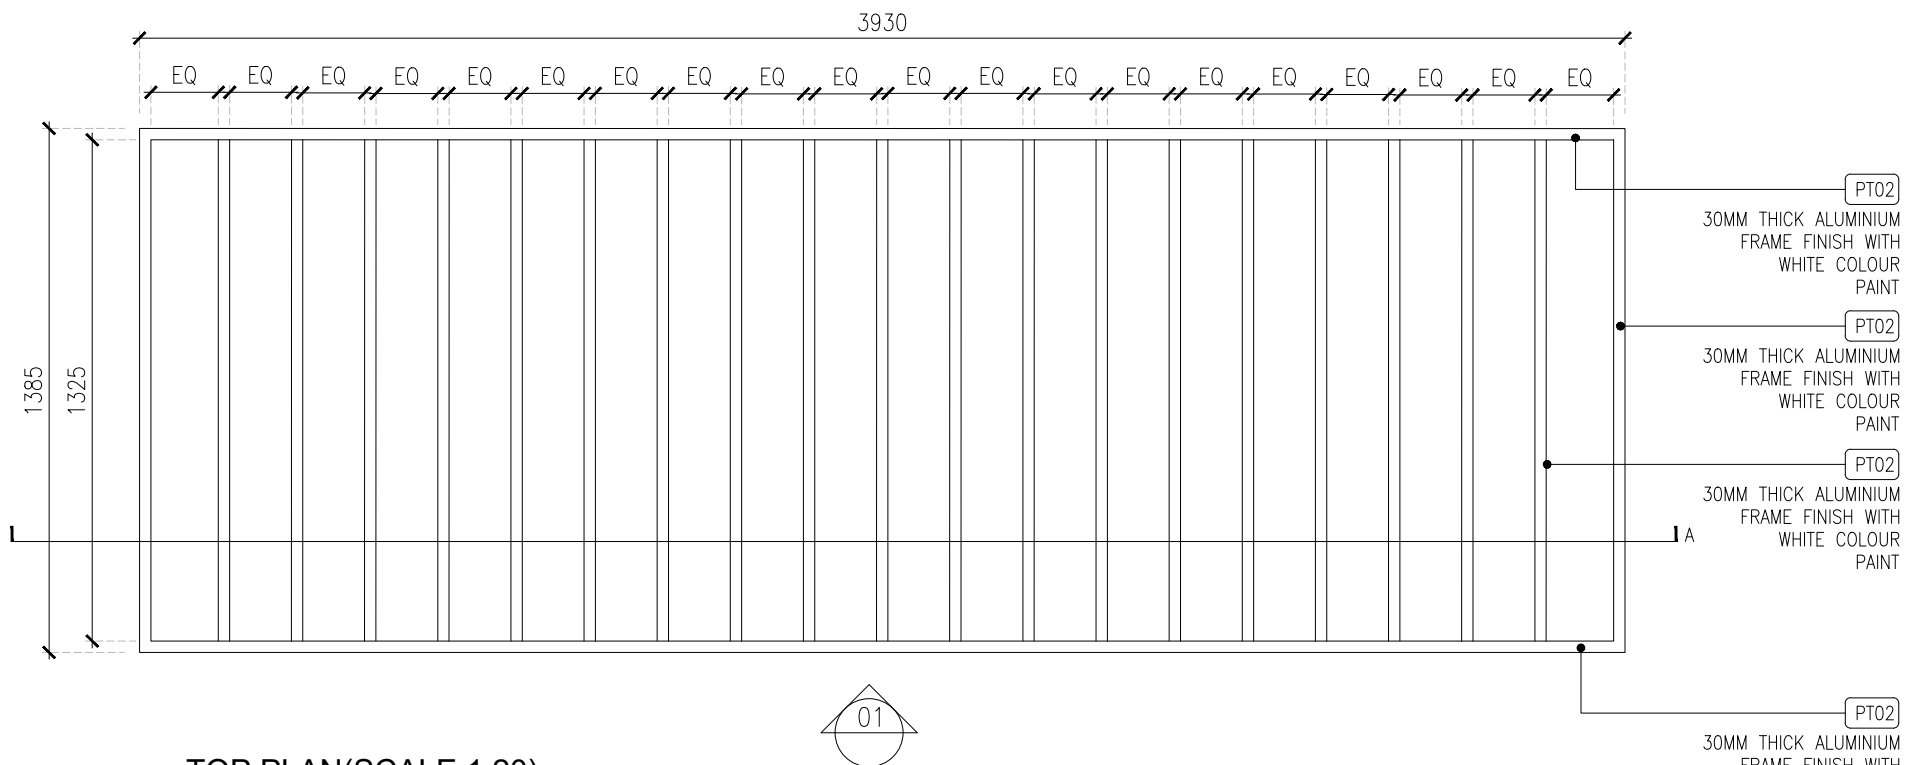


TOP PLAN(SCALE 1:20)

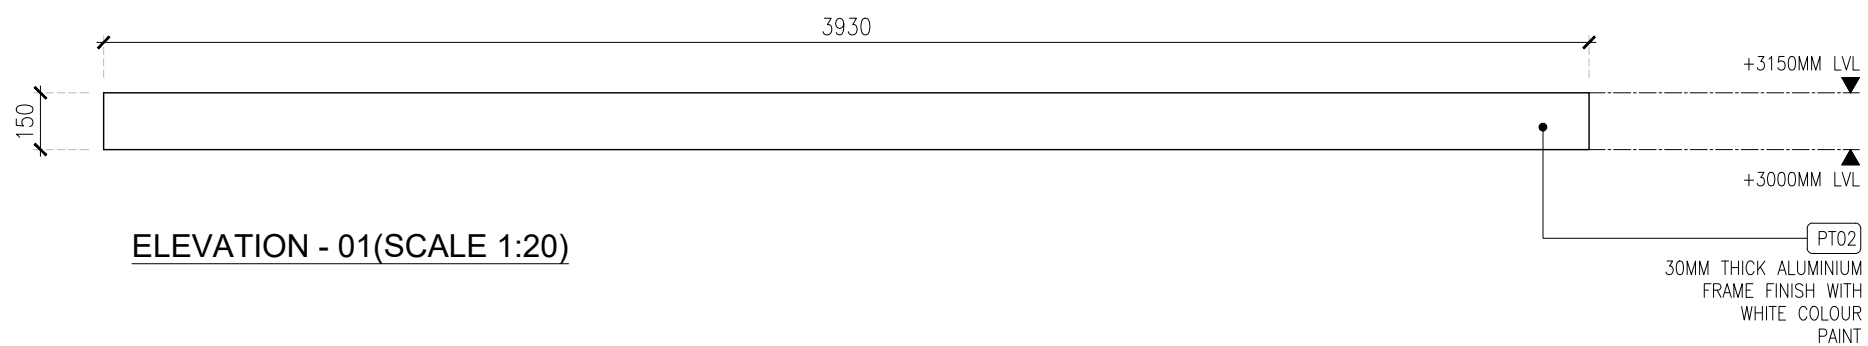

ELEVATION - 01(SCALE 1:20)

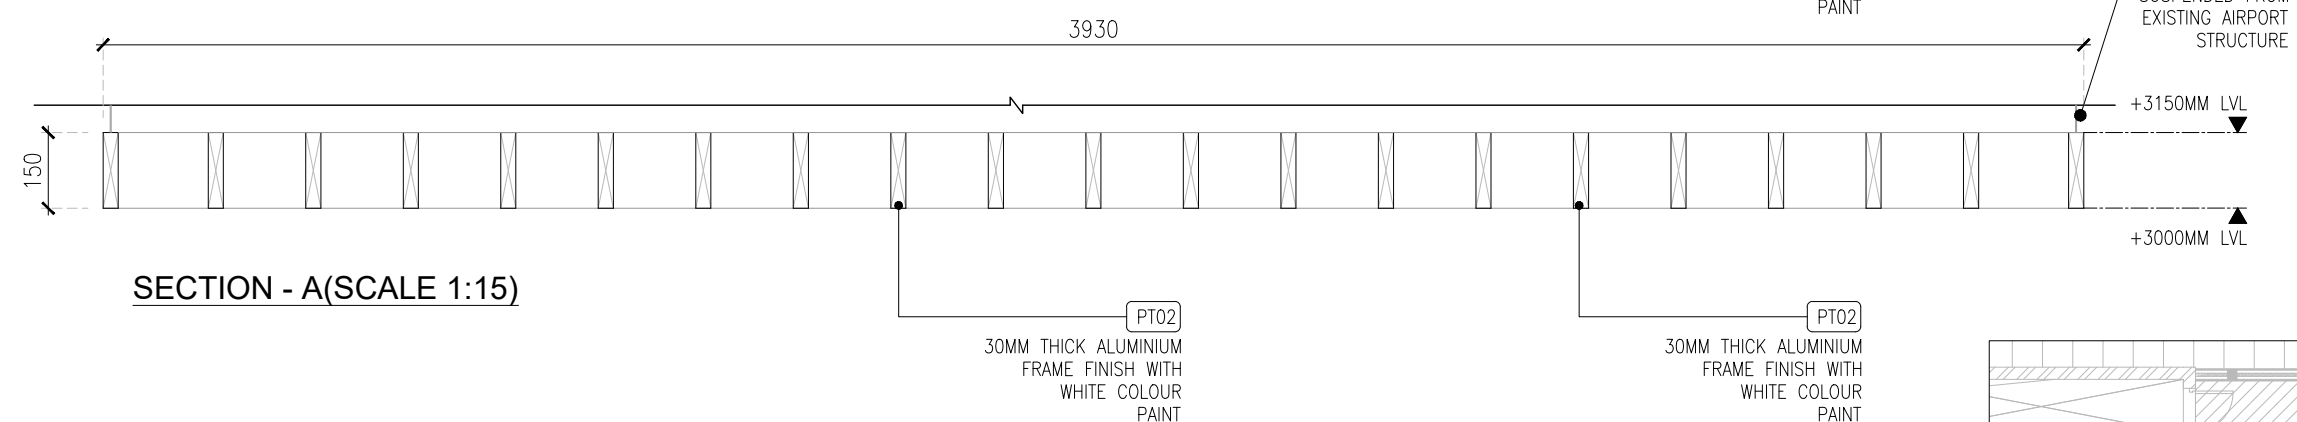

SECTION - A(SCALE 1:15)

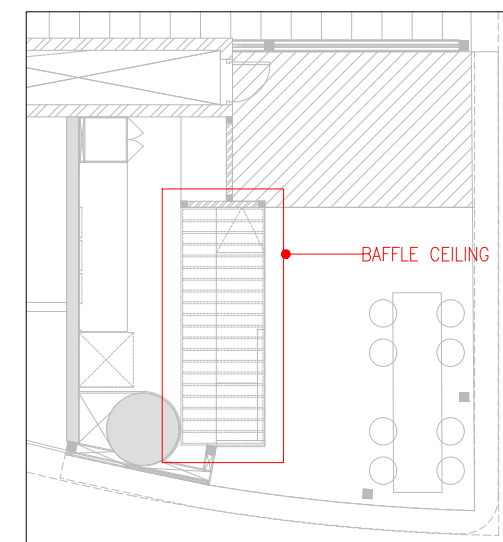

KEY PLAN

01 J07 - BAFFLE CEILING DETAIL  
04DE-408

REV	DATE	DESCRIPTION	HOD	NM	DRN	CHK
C01	19.02.24	GOOD FOR CONSTRUCTION				



PROJECT  
FF-045  
MILIE COOKIES  
HYDERABAD AIRPORT

DRAWING TITLE  
J07 - BAFFLE CEILING DETAIL

SCALE AS MENTIONED DATE 19.02.2024 DRAWN HOD A3 SHEET

STATUS  
GOOD FOR CONSTRUCTION

ORG	PROJECT NO	DRAWING TYPE	NUMBER	REV
TFS	XXXX	04DE	408	C01




01 LIT SIGNAGE-01 (SG01)(2 Nos)  
04DE-409 1:15

50MM THK FRONT LIT FRET CUT LETTERS WITH 3MM THK TURQUOISE BLUE COLOUR (RAL:5018) ACRYLIC SHEET ON FRONT & ALUMINUM SHEET ON BACK



02 LIT SIGNAGE-02 (SG02)  
04DE-409 1:10

50MM THK FRONT LIT FRET CUT LETTERS WITH 3MM THK TURQUOISE BLUE COLOUR (RAL:5018) ACRYLIC SHEET ON FRONT & ALUMINUM SHEET ON BACK

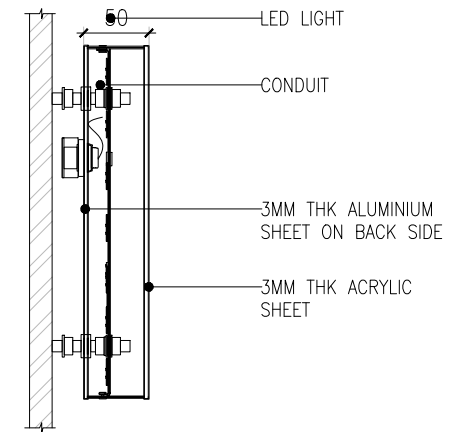


TYPICAL SECTION OF FRONT LIT SIGNAGE



03 LIT SIGNAGE-03 (SG03)  
04DE-409 1:10

50MM THK FRONT LIT FRET CUT LETTERS WITH 3MM THK WHITE COLOUR ACRYLIC SHEET ON FRONT & ALUMINUM SHEET ON BACK

50MM THK FRONT LIT FRET CUT LETTERS WITH 3MM THK WHITE COLOUR ACRYLIC SHEET ON FRONT & ALUMINUM SHEET ON BACK

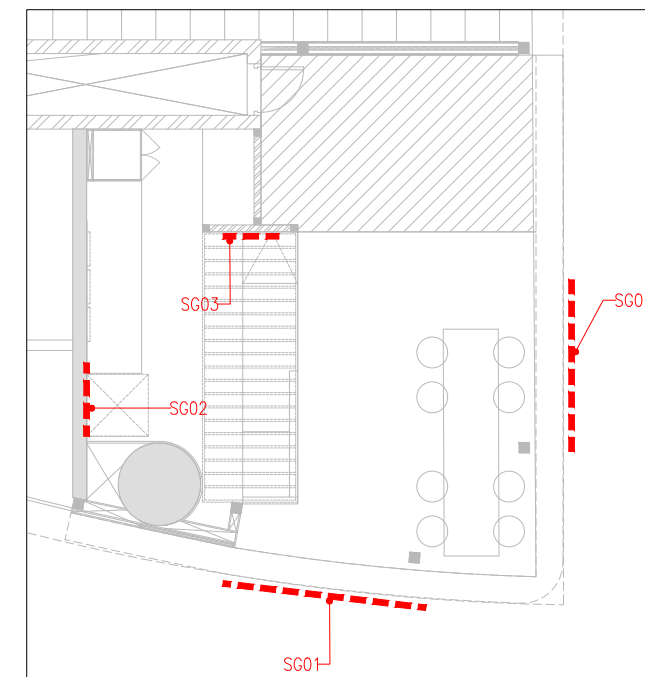

KEY PLAN

REV	DATE	DESCRIPTION	HOD	NM
C01	19.02.24	GOOD FOR CONSTRUCTION		



PROJECT  
FF-045  
MILLIE COOKIES  
HYDERABAD AIRPORT

DRAWING TITLE  
J08 - SIGNAGE DETAIL

SCALE AS MENTIONED DATE 19.02.2024 DRAWN HOD A3 SHEET

STATUS  
GOOD FOR CONSTRUCTION

ORG PROJECT NO DRAWING TYPE NUMBER REV  
TFS XXXX 04DE 409 C01