


CCTV & NETWORKING LEGENDS		
SYMBOL	DESCRIPTION	QTY
	DOME CCTV CAMERA – IP67 CEILING MOUNT	03
	DOME CCTV CAMERA – IP67 WALL MOUNT (ONLY CABLING BETWEEN THE CAMERA AND MUTOA)	01
	DVR FOR CCTV	01
	CCTV CABLE	--

NOTES

- ALL DIMENSIONS & LEVEL ARE IN "MM" OR OTHERWISE MENTIONED.
- CCTV TO BE FIXED TO CEILING COORDINATING WITH LIGHTS, SPRINKLERS AND DETECTORS FOR AVOID CLASHES.
- THE CABLE ROUTING SHOWN IN THE DIAGRAM IS INDICATIVE SCHEMATIC ONLY. ACTUAL ROUTING IS TO BE DONE AS PER SITE CONDITION AND ALSO COORDINATE WITH OTHER SERVICES.
- ONLY FIXED TYPE CAMERA SHALL BE USED. NO PAN / TILT TYPE CAMERA IS ALLOWED.
- CAT6 CABLE OF BELDEN MAKE FOR EPOS CAMERA SHALL BE BROUGHT TO THE LOCATION ABOVE POS.
- IT CABLE TO BE TERMINATED WITH IO AND NEED TO LEFT AT CEILING HEIGHT FOR FIXING EPOS CAMERA. (THIS WILL BE DONE BY GMR IT TEAM).
- BACKUP SHOULD BE 45 DAYS.

ALL DIMENSIONS MUST BE CHECKED ON SITE. INFORM THE ENGINEER OF ANY DISCREPANCIES PRIOR TO CONSTRUCTION.

NOTES:
IRRESPECTIVE OF THE DRAWING(S), IT IS THE CONTRACTOR'S OBLIGATION AND RESPONSIBILITY THAT SHALL BE EXECUTED AND COMPLETED IN ACCORDANCE TO THE SPECIFICATION, DRAWING(S) AS WELL AS REQUIREMENT. THE SAID DRAWING(S) SHALL NOT RELIEVE CONTRACTOR FROM ITS OBLIGATION UNDER THE CONTRACT AND IN PARTICULAR FROM ITS RESPONSIBILITY IN RELATION TO THE INSTALLATION MATERIALS AND WORKMANSHIP AND WHERE RELEVANT FROM A DUTY TO SEEK APPROVAL FROM THE COMPETENT AUTHORITY.

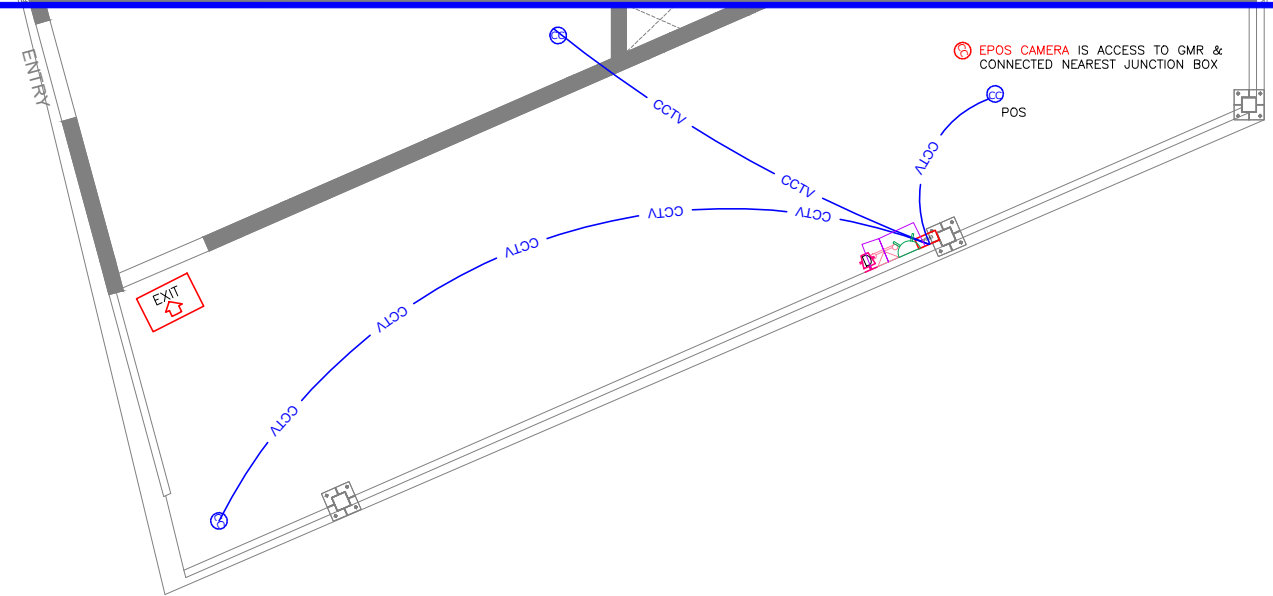

NOTE: CAT6 CABLE OF BELDEN MAKE SHALL BE MADE AVAILABLE ABOVE POS BELOW CEILING FOR FIXING GMR-EPOS CAMERA. EPOS CAMERA FIXING IN GMR SCOPE

ELECTRICAL LEGEND-CONDUIT	
SYMBOL	DESCRIPTION
	25mmØ PVC CONDUIT FOR POWER
	25mmØ PVC CONDUIT FOR LIGHTING
	25mmØ PVC CONDUIT FOR TEL&DATA
	25mmØ PVC CONDUIT FOR POINT WIRING
	25mmØ PVC CONDUIT FOR CCTV
	25mmØ PVC CONDUIT FOR EMERGENCY LIGHTING

	12 mm PROFILE LIGHT
	HANGING LIGHT(5NO)
	DOWNLIGHT COB 3000KV
	CCTV
ALL LIGHTS ARE 30Watts	
ALL LIGHTS ARE WARM LIGHT	

C02	22.05.24	GOOD FOR CONSTRUCTION	AK	VJ
REV	DATE	DESCRIPTION	DRN	CHK



PROJECT
FF025
MILLIE COOKIES & CREAMSTONE
HYDERABAD AIRPORT

DRAWING TITLE
CCTV LAYOUT

SCALE 1:75 DATE 22.05.24 DRAWN AK A3 SHEET

STATUS
GOOD FOR CONSTRUCTION

ORG PROJECT NO DRAWING TYPE NUMBER REV
TFS XXXX ELEC E501 C02