




INHOUSE DESIGN

CURRY KITCHEN CART @ GUWAHATI

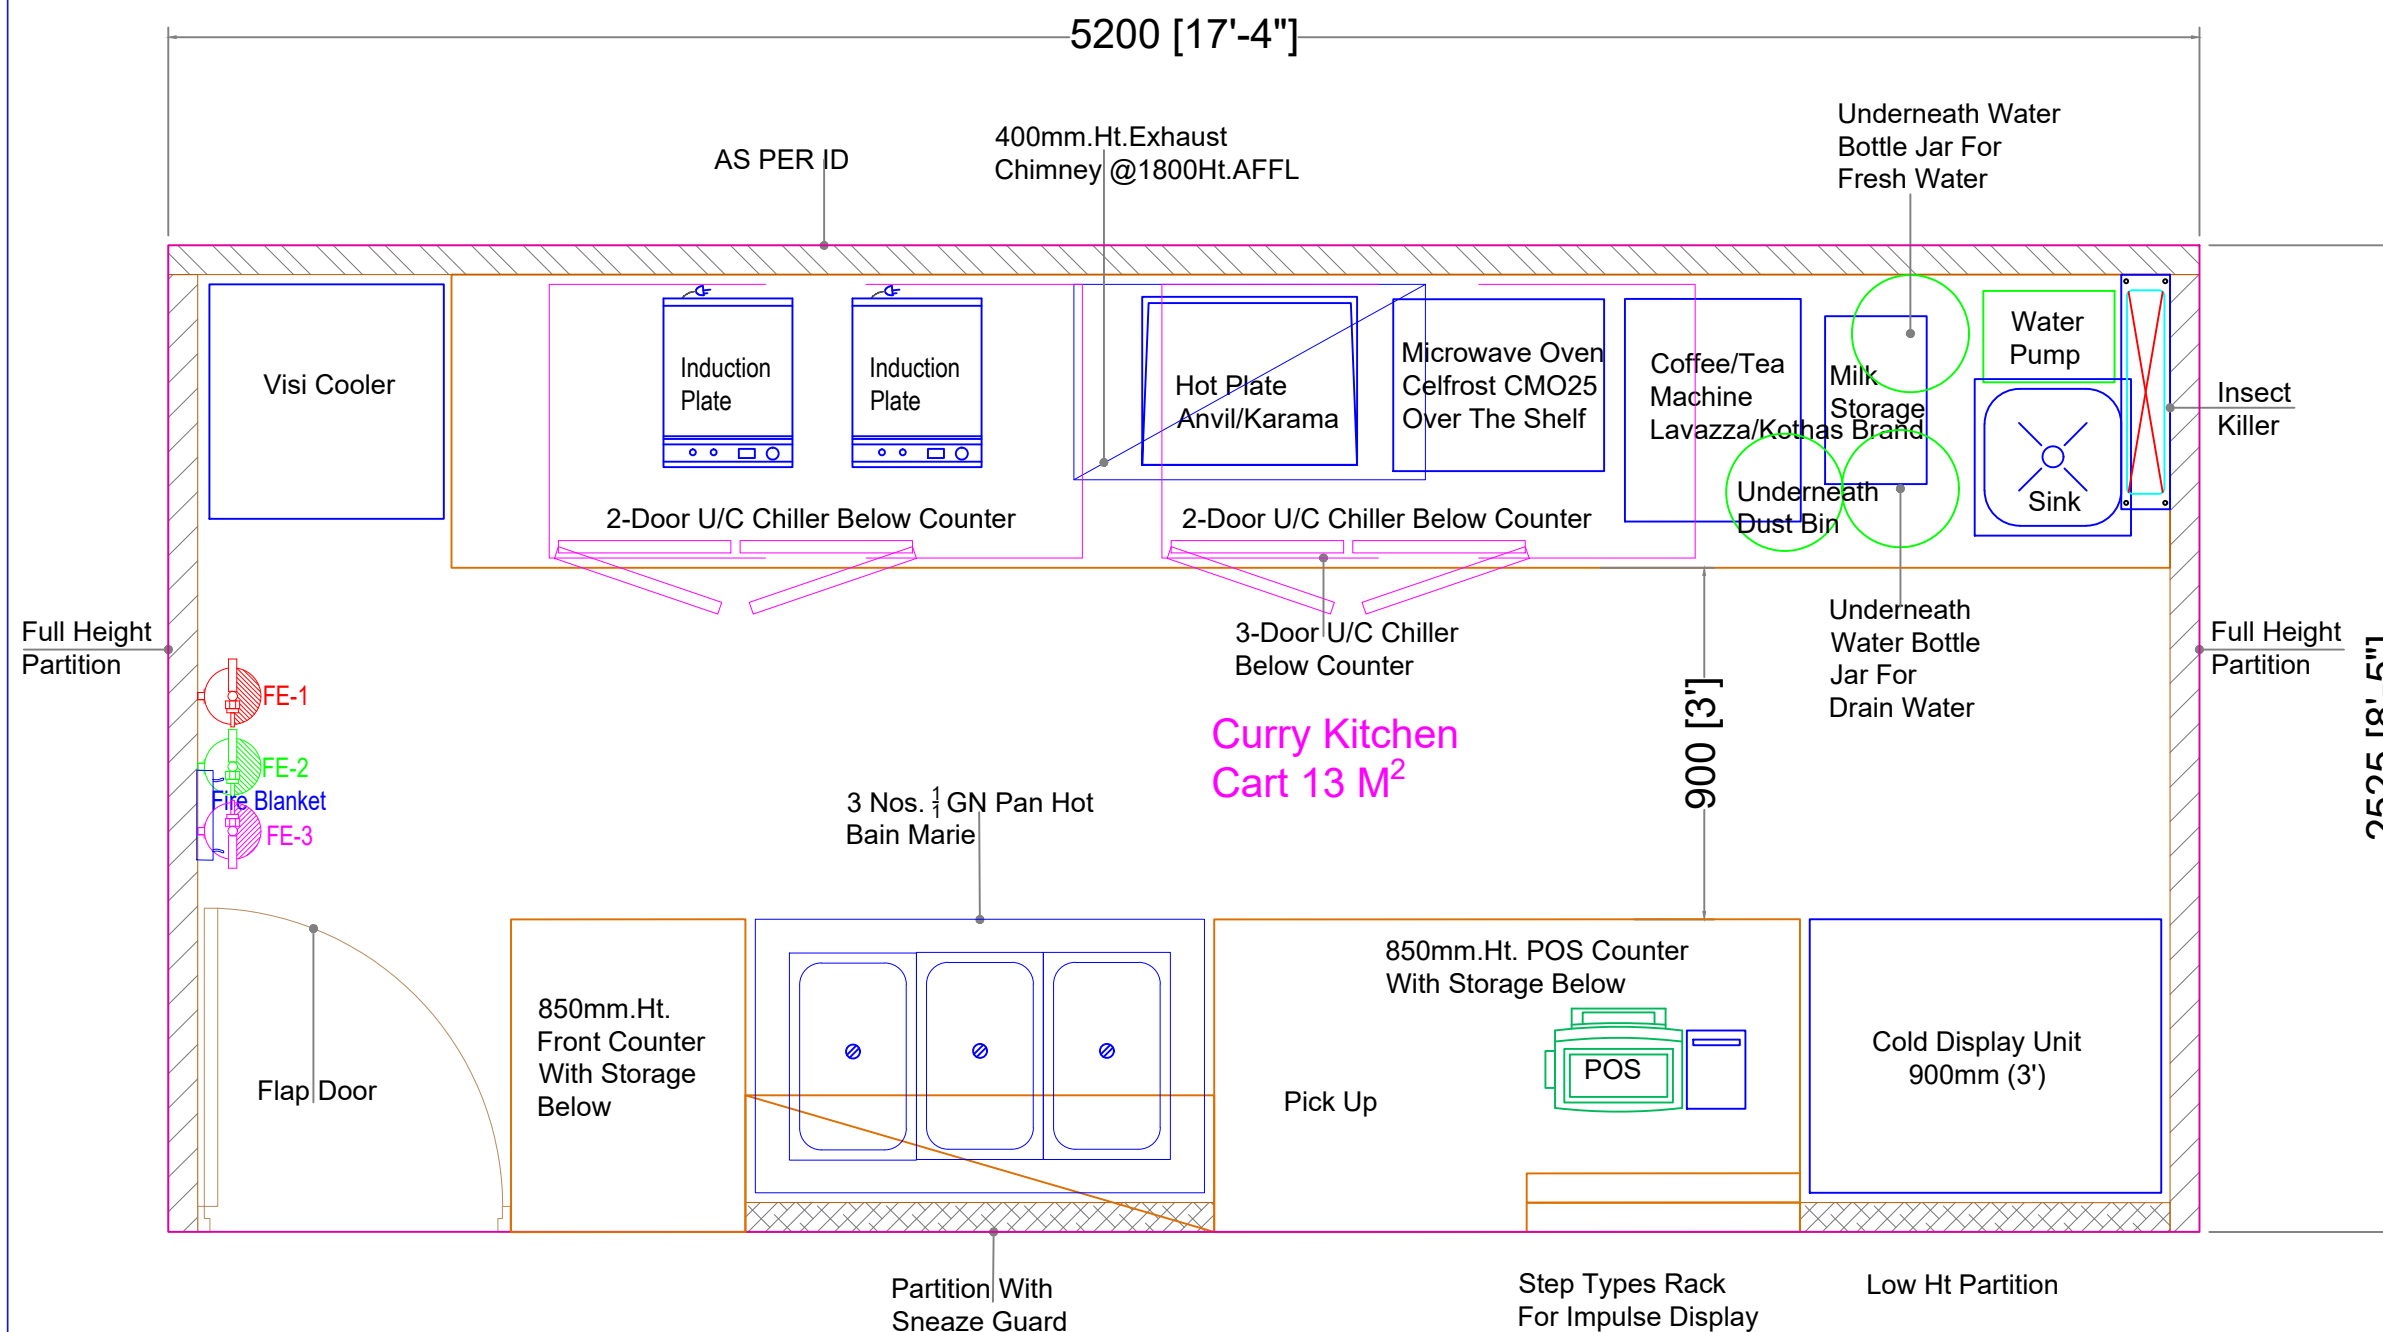


SYMBOL	DESCRIPTION	QTY.
FE-1	Fire Extinguisher ABC-4Kg	02 Nos.
FE-2	Fire Extinguisher CO ₂ -4.5Kg	02 Nos.
FE-3	Fire Extinguisher KType - 6Kg	01 Nos.
Fire Blanket	Fire Blanket - 6' X 4'	02 Nos.

PROJECT	LOCATION	DRAWN BY	START DATE	CHK BY	DATE	REVISION No.	FINAL APPROVED	DRAWING	DRAWING NAME	SHEET NUMBER
CURRY KITCHEN CART	GUWAHATI	SAEED	17-01-24			-	DATE		EQUIP NAMING LAYOUT	01 OF 03
		DWG.No.	SCALE	REVISION DATE :						
		----	NTS.	-						



INHOUSE DESIGN

**CURRY KITCHEN
CART
@
GUWAHATI**

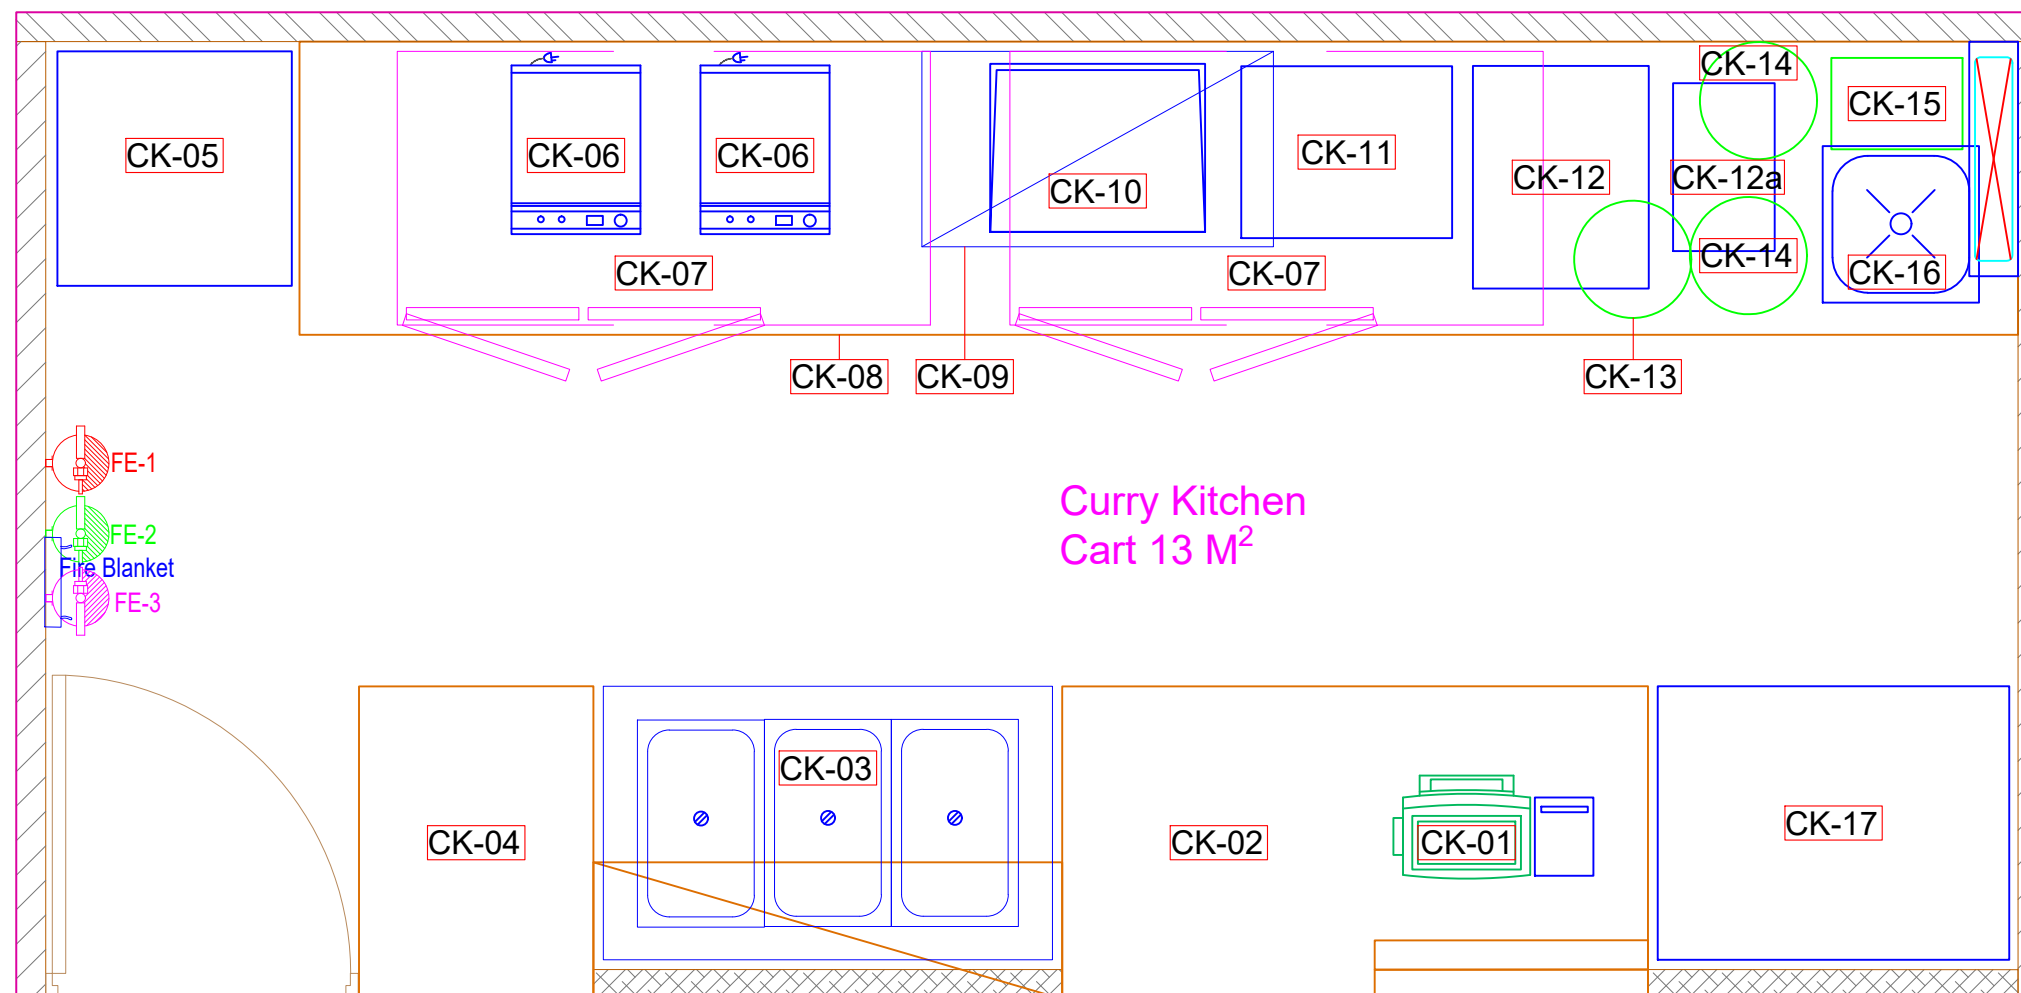


Curry Kitchen
Cart 13 M²

PROJECT	LOCATION	DRAWN BY	START DATE	CHK BY	DATE	REVISION No.	FINAL APPROVED	DRAWING	DRAWING NAME	SHEET NUMBER
CURRY KITCHEN CART	GUWAHATI	SAEED	17-01-24			-	DATE		EQUIP NUMBERING LAYOUT	
		DWG.No.		SCALE		REVISION DATE :				
		----		NTS.		-				



INHOUSE DESIGN

CURRY KITCHEN CART @ GUWAHATI

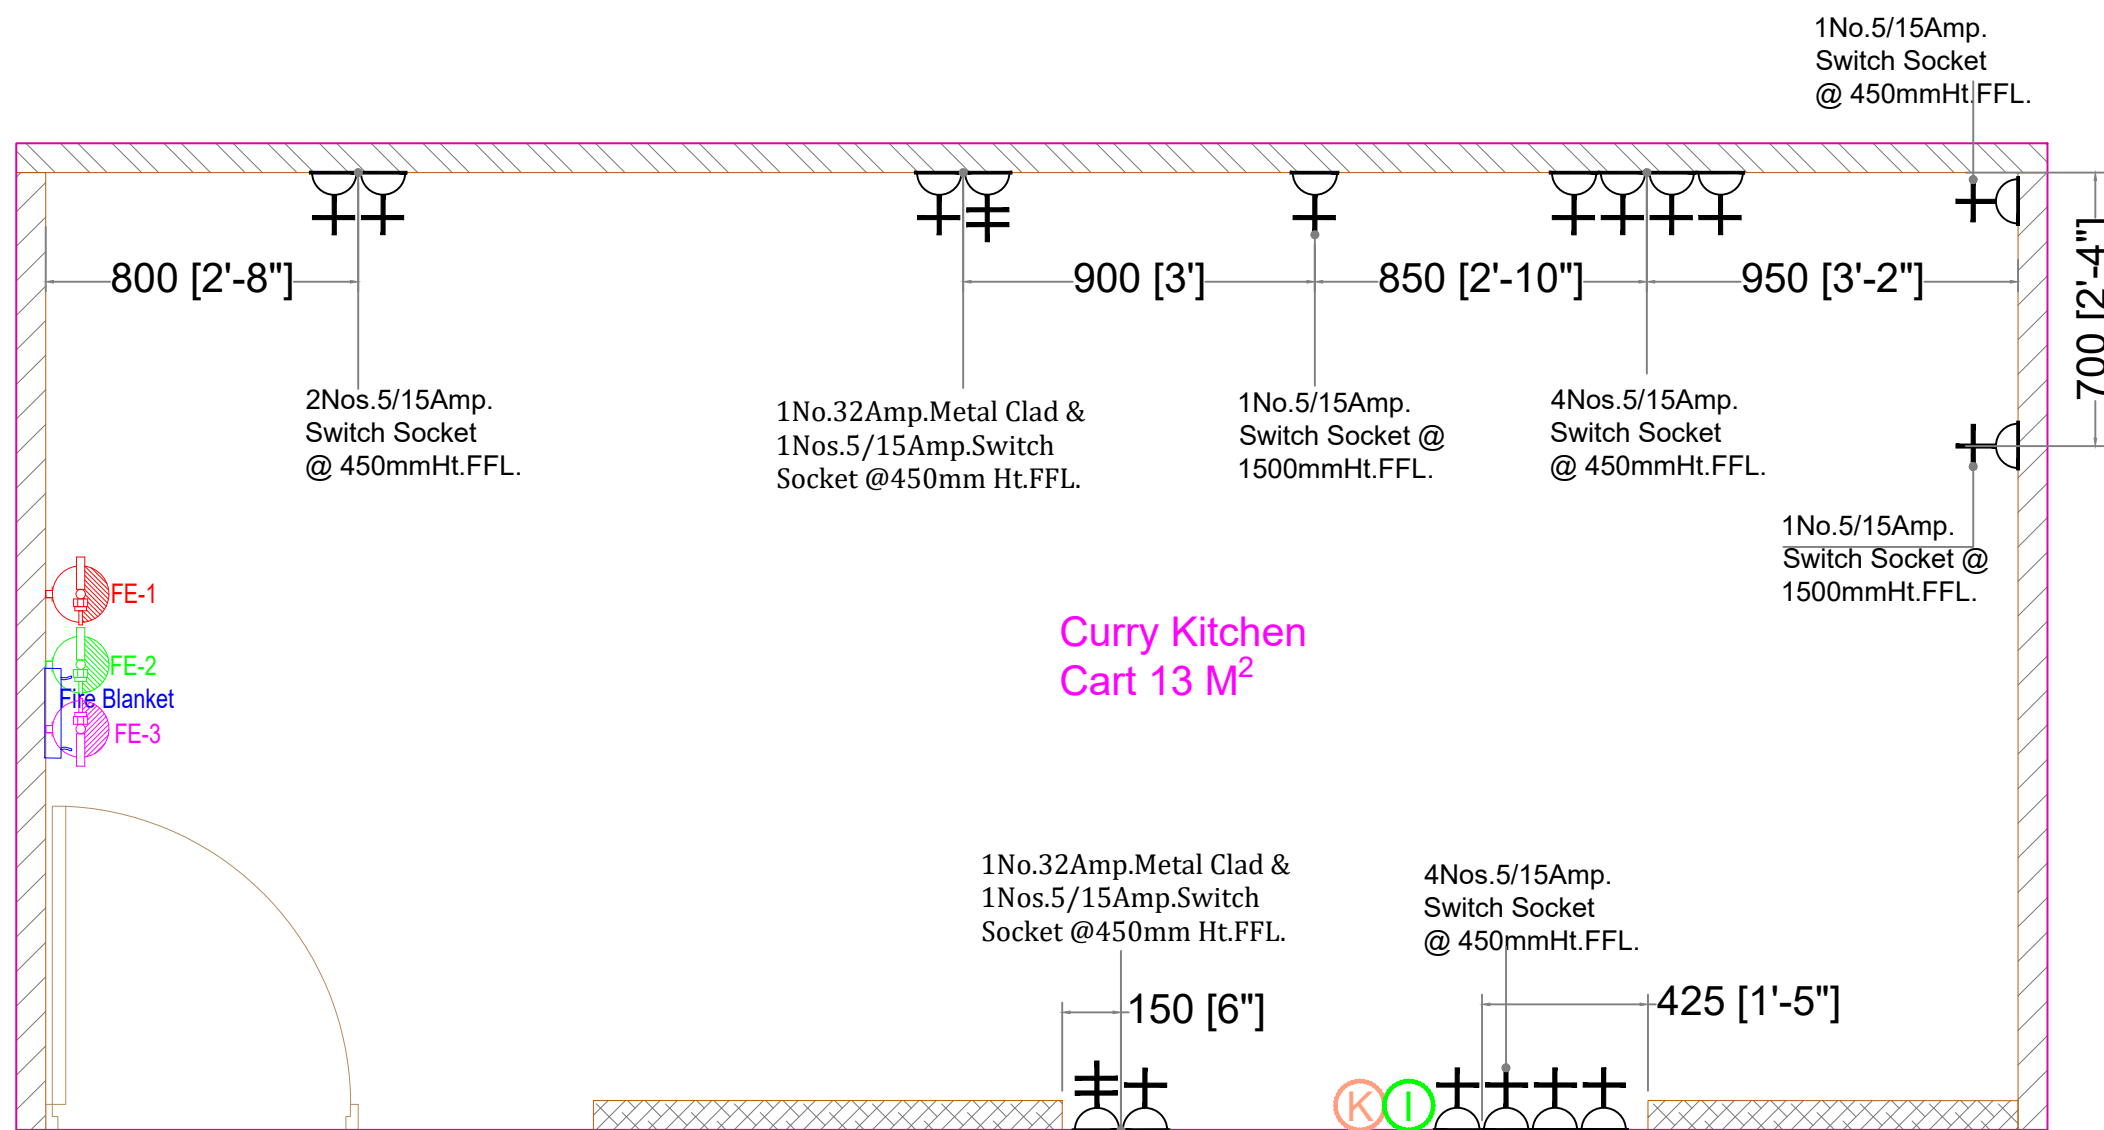

Curry Kitchen
Cart 13 M²

ELECTRICAL LEGEND	
	5 AMP PLUG POINT
	5/15 AMP POWER PLUG POINT (MODULAR SWITCH & SOCKET)
	20/32 AMP METAL CLAD WITH 20 AMP SP MCB & PLUG TOP
	3 PHASE SUPPLY
	COMPUTER POINT
	TELEPHONE POINT
	DATA CABLE POINT FOR KOT PRINTER
	INTERNET

PROJECT	LOCATION	DRAWN BY	START DATE	CHK BY	DATE	REVISION No.	FINAL APPROVED	DRAWING	DRAWING NAME	SHEET NUMBER
CURRY KITCHEN CART	GUWAHATI	SAEED	17-01-24			-	DATE		ELECTRIC LAYOUT	
		DWG.No.	SCALE	REVISION DATE :						
		----	NTS.	-						