


01 CCTV & DATA LAYOUT

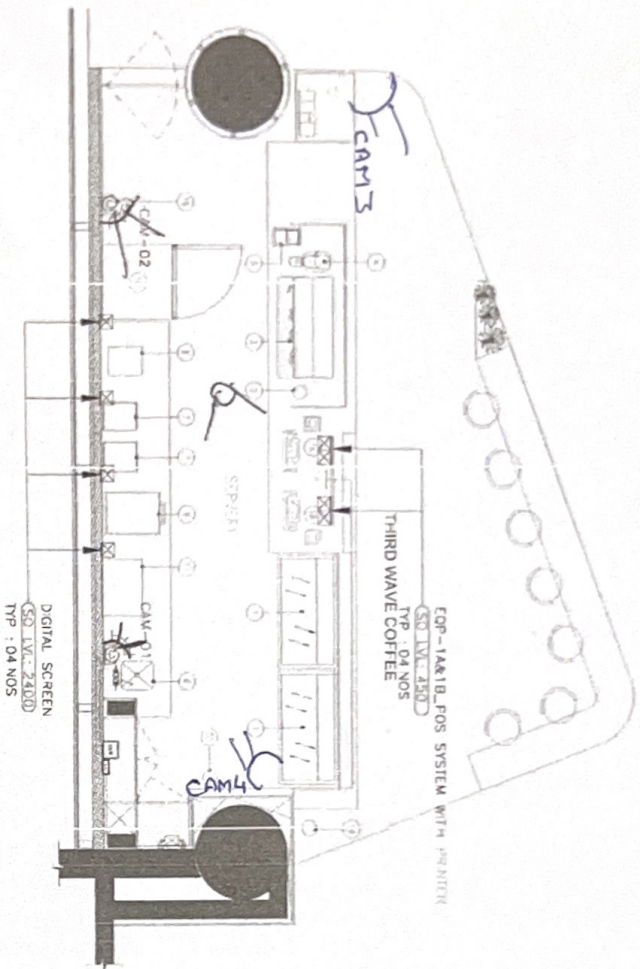

LEGENDS - CCTV & NETWORKING SYSTEM

SYMBOL	DESCRIPTION	QTY
	DOVE CCTV CAMERA - IP67 - WALL MOUNT	02
	WIFI POINT	01
	8 CHANNEL DVR	01
	8 PORT SWITCH FOR TELEPHONE CONNECTIVITY	01
<input checked="" type="checkbox"/>	RJ45 FOR DATA OUTLET	08
	CCTV CABLE	--
	CAT-6 CABLE FOR DATA AND TELEPHONE	--

NOTES:

- THE CABLE ROUTING SHOWN IN THE DIAGRAM IS INDICATIVE ONLY. ACTUAL ROUTING IS TO BE DONE AS PER SITE CONDITION AND ALSO COORDINATE WITH OTHER SERVICES.
- ONLY FIXED TYPE CAMERA SHALL BE USED. NO PAN/TILT TYPE CAMERA IS ALLOWED.
- CONTRACTOR TO FOLLOW AIRPORT VEEA GUIDELINES FOR MATERIALS SPECIFICATION AND ACTIVATION PROCESS.
- THE POSITION OF THE WIFI ROUTER IS INSIDE THE POS COUNTER.

ALL DIMENSIONS SHOWN ARE IN METERS UNLESS OTHERWISE SPECIFIED.  
 ALL DIMENSIONS SHOWN ARE IN METERS UNLESS OTHERWISE SPECIFIED.  
 ALL DIMENSIONS SHOWN ARE IN METERS UNLESS OTHERWISE SPECIFIED.  
 ALL DIMENSIONS SHOWN ARE IN METERS UNLESS OTHERWISE SPECIFIED.

DATE: 08/11/23  
 DRAWN BY: [Name]  
 CHECKED BY: [Name]



PROJECT: THIRD WAVE COFFEE STORE 2 @ L1 LEVEL  
 T1, IGI AIRPORT DELHI  
 DRAWN BY: [Name]  
 CHECKED BY: [Name]

SCALE: 1:50  
 SHEET: 01 OF 10  
 CONSTRUCTION  
 PROJECT NO: 0000  
 ELEC: E501 C00