

PROJECT

PROJECT LOCATION

BLOCK

BLOCK

General Notes :

1. All dimensions are in millimeters.
2. Dimensions are to be read and not to be scaled.
3. The contractors must verify all dimensions on site and refer the relevant STRUCTURAL and other MEP drawings before commencing any work or preparing shop drawings, and in case any discrepancy is noticed the same shall be brought to the notice of the architect and shall be clarified before execution of work.
4. Refer this drawing along with the other relevant architectural, structural and MEP services drawings.
5. All Sill & Lintel levels to be considered from FFL

MEP CONSULTANTS:
PILLARPLUS PVT LTD-The New Age MEP Consultancy Firm
 Plot No. 45,46 guru Jambheshwar Nagar A,
 Vijay Dwar, Gandhipath, Jaipur-302021
 JAIPUR | GURGAON | BANGLORE
 Email: contact@pillarplus.com | Contact No: +91-9799858301 | Website: www.pillarplus.com


DRAWING TITLE:
GROUND FLOOR BIKANERWALA HVAC

NORTH	DRAWING NO	Rev.		
	PP/HVAC/01			
SCALE	DATE	PREP	CHKD	APPVD
	17.1.2024	WASIM	BHANU JAIN	

Rev.	Date	Description	Approved

Revision Index

CLIENT
CLIENT ADDRESS

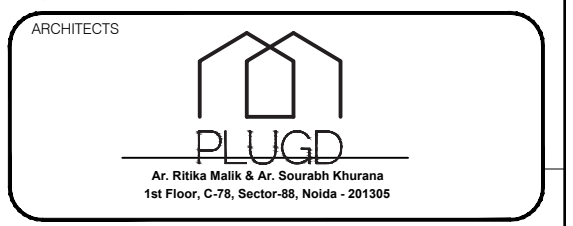


DRAWING TITLE
DRAWING-TITLE

<input type="checkbox"/> FOR TENDER	DATE	PROJ ARCHITECT :
<input type="checkbox"/> FOR INFORMATION	DATE	PROJ ARCH
<input type="checkbox"/> FOR EXECUTION	SCALE	DRAWN-BY
<input type="checkbox"/> FOR APPROVAL	SCALE	CHECKED
		CHECKED-BY

DRAWING NO _____ REVISION _____
DRAWING-NO. _____ **REVISION-NO.** _____

PLUGD
 C-78, Sector 88, Noida-201305
 The contents of this drawing constitute the original and unpublished work of PLUGD and no part of the drawing shall be disclosed / modified / used in any manner without their prior consent.

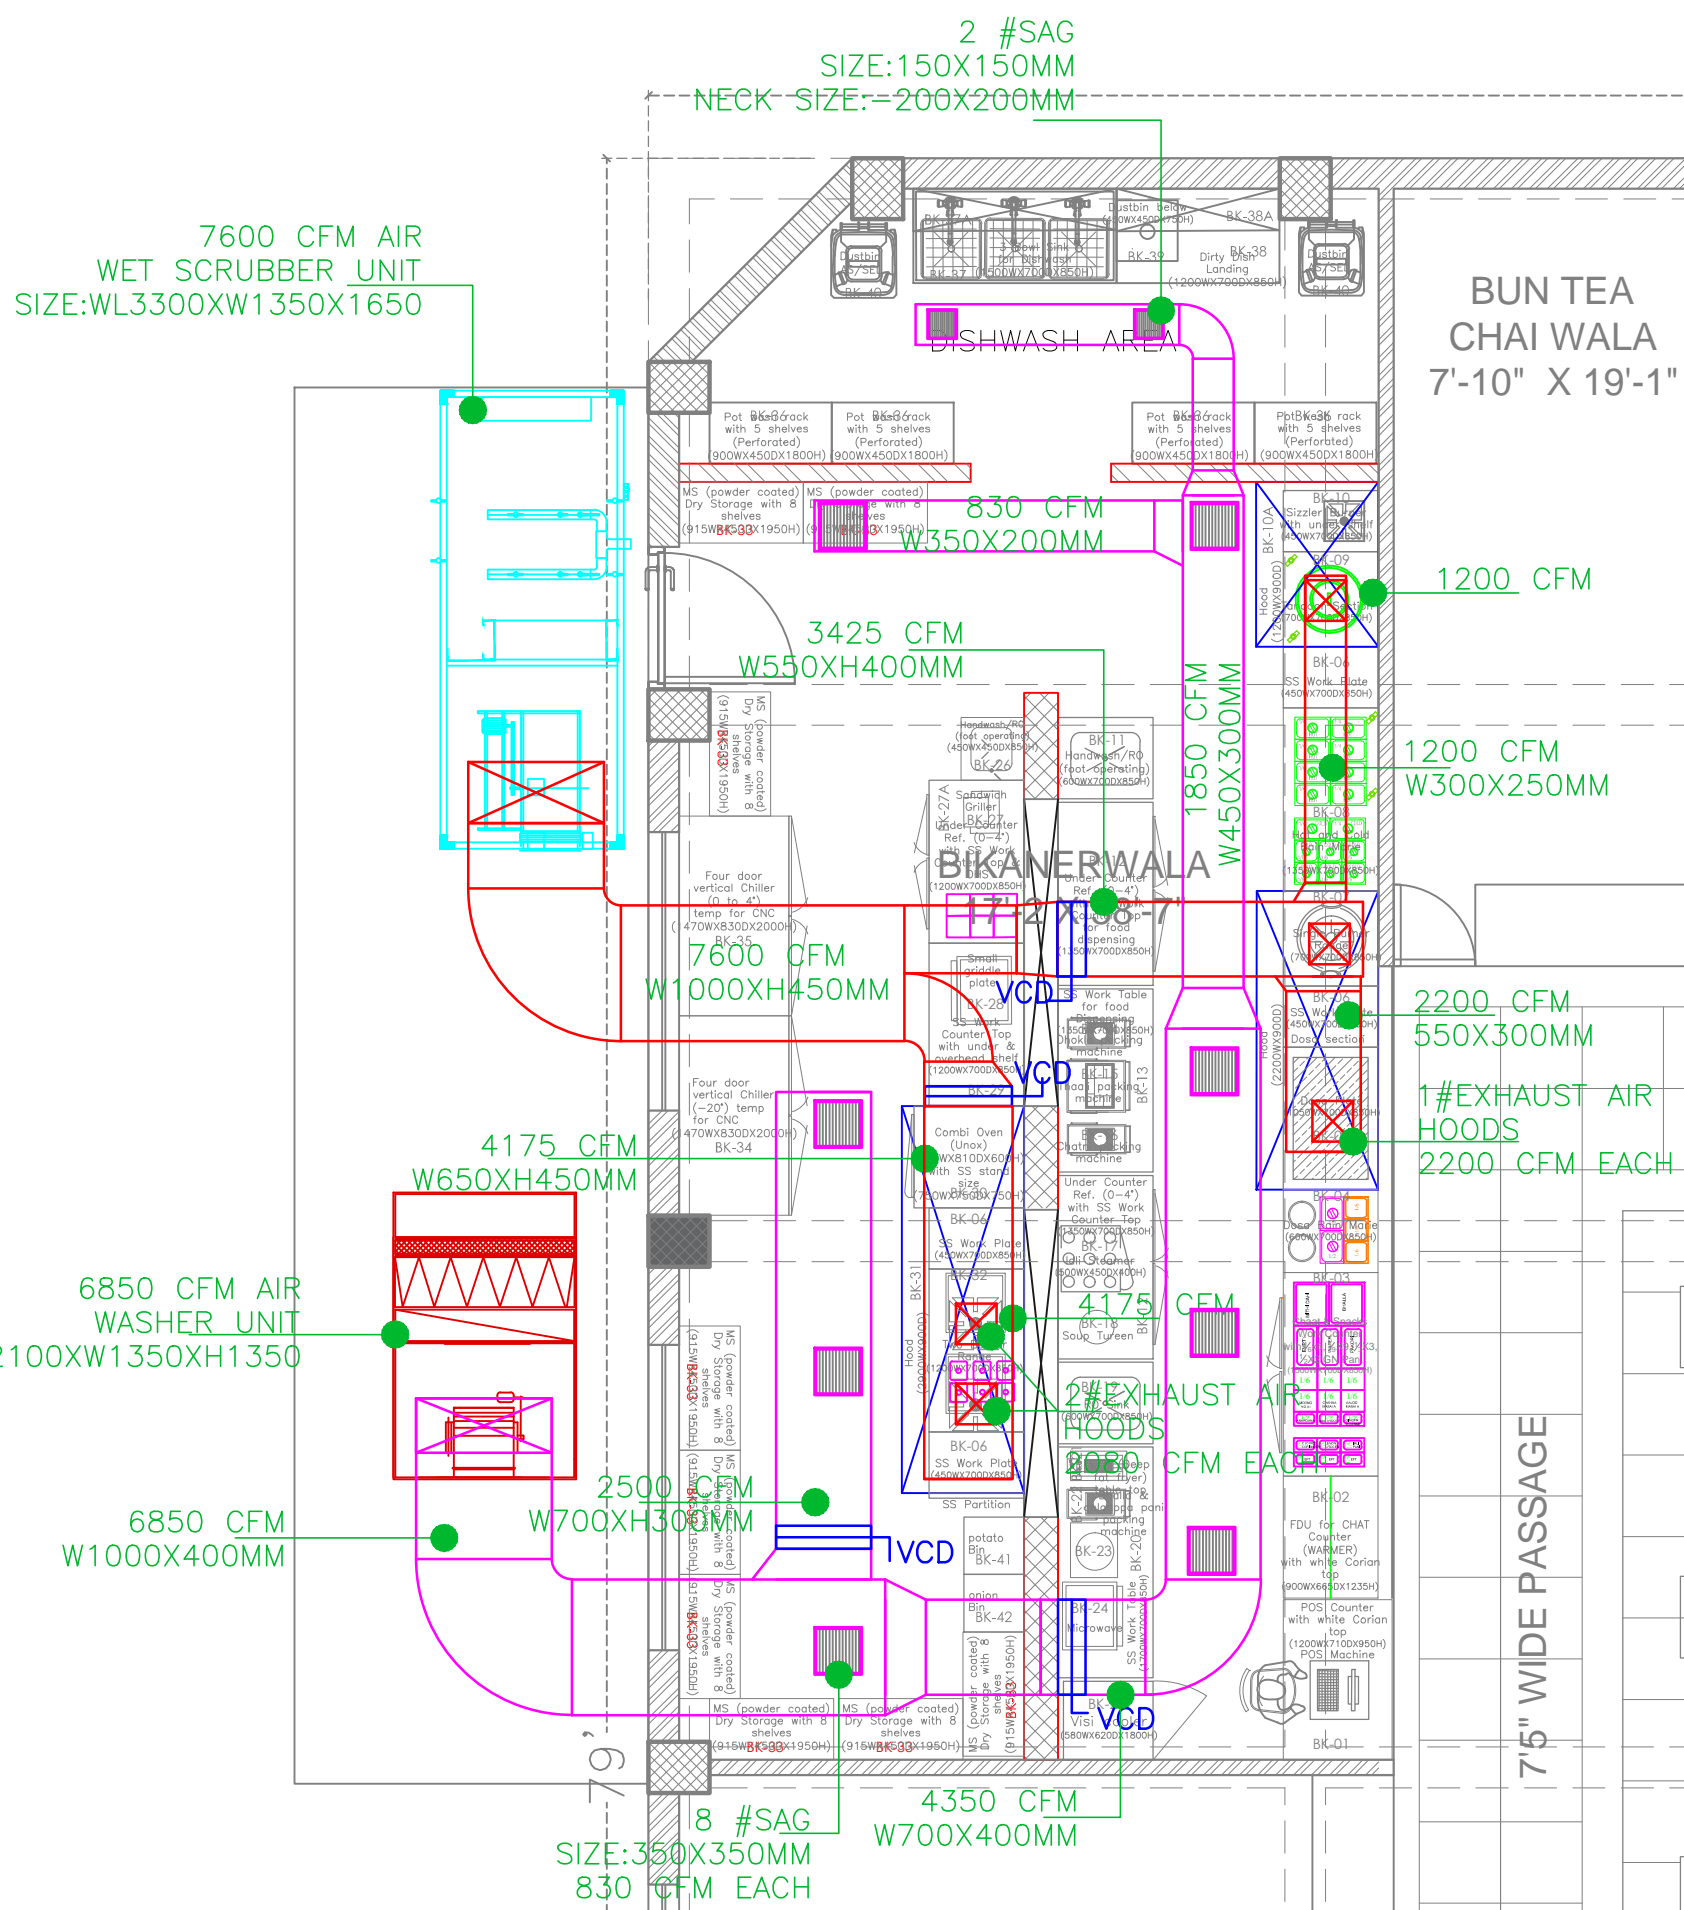

HVAC LEGEND

S.NO	DESCRIPTION	SYMBOLS
0.1	AIR SCRUBBER	
0.2	AIR WASHER	
0.3	DUCT ABLE UNIT	
0.4	CASSETTE AC	
0.5	HI WALL UNIT	
0.6	IN LINE FAN	
0.7	EXHAUST AIR DUCT	
0.8	AC REFRIGERANT PIPE	
0.9	AC DRAIN PIPE	
0.10	SUPPLY AIR DUCT	
0.11	AIR WASHER DUCT	
0.12	AIR SCRUBBER DUCT	