

PROJECT
AIRPORT,
HYDERABAD

CLIENT
TACO BELL

NOTE:

THIS DRAWING & DESIGN IS THE COPYRIGHT OF THE DESIGNER. NO PORTION MAY BE REPRODUCED WITHOUT THE WRITTEN PERMISSION OF THE DESIGNERS

1. ALL DIMENSIONS ARE INCLUDING FINISHES
2. DO NOT SCALE DRAWING. ONLY MENTIONED DIMENSIONS ARE TO BE CONSIDERED.
3. ALL DIMENSIONS MUST BE CHECKED BEFORE COMMENCING WORK ON SITE.
4. ANY DISCREPANCIES SHALL BE BROUGHT UNDER THE NOTICE OF ARCHITECTS PRIOR COMMENCEMENT OF WORK.

CHECK POINTS:

- 1) ALL THE LEVELS ARE FROM RESPECTIVE FINISH FLOOR LVL.
- 2) 24X24 MM PERIMETER TRIM TO BE USED.
- 3) METAL GRID CEILING DETIL TO BE FOLLOWED.
- 4) FOH CEILING SLAB/ STRUCTURE MEMBERS RACEWAY/ HANGING LIGHTS/ DUCTS/ OPEN CABLE TO BE PAINTED WITH GREY PAINT (DULUX 53BB 36/004 GREY COUTURE).

REVISION

S.NO.	REMARKS	DATE
1	REV 1	12-12-2023
2	REV 2	21-12-2023
3	REV 3	00/00/00
4	REV 4	00/00/00
5	REV 5	00/00/00
6	REV 6	00/00/00
7	REV 7	00/00/00
8	REV 8	00/00/00

ARCHITECT / INTERIOR DESIGN

ARCHITECT
STUDIO
ARCHITECTURE PLANNING
INTERIOR FURNITURE
FLAT NO-13 DDA SFS
SLAT POCKET -1 SEC-6 DWARKA,
NEW DELHI-110075
EMAIL- info@stata@gmail.com
OFF-011-35559249, MOB-9910315171

CONSULTANT

CONSULTANT

RELEASE FOR

INFORMATION | TENDER | CONSTRUCTION | AS BUILT

TITLE

LIGHTING LAYOUT

DATE | 17-10-2023


SCALE | NTS

DRAWN BY | AR. MANISH

CHECKED BY | AR. ANKIT

PRINTED BY | -

DWG. NO. | WD-D-20

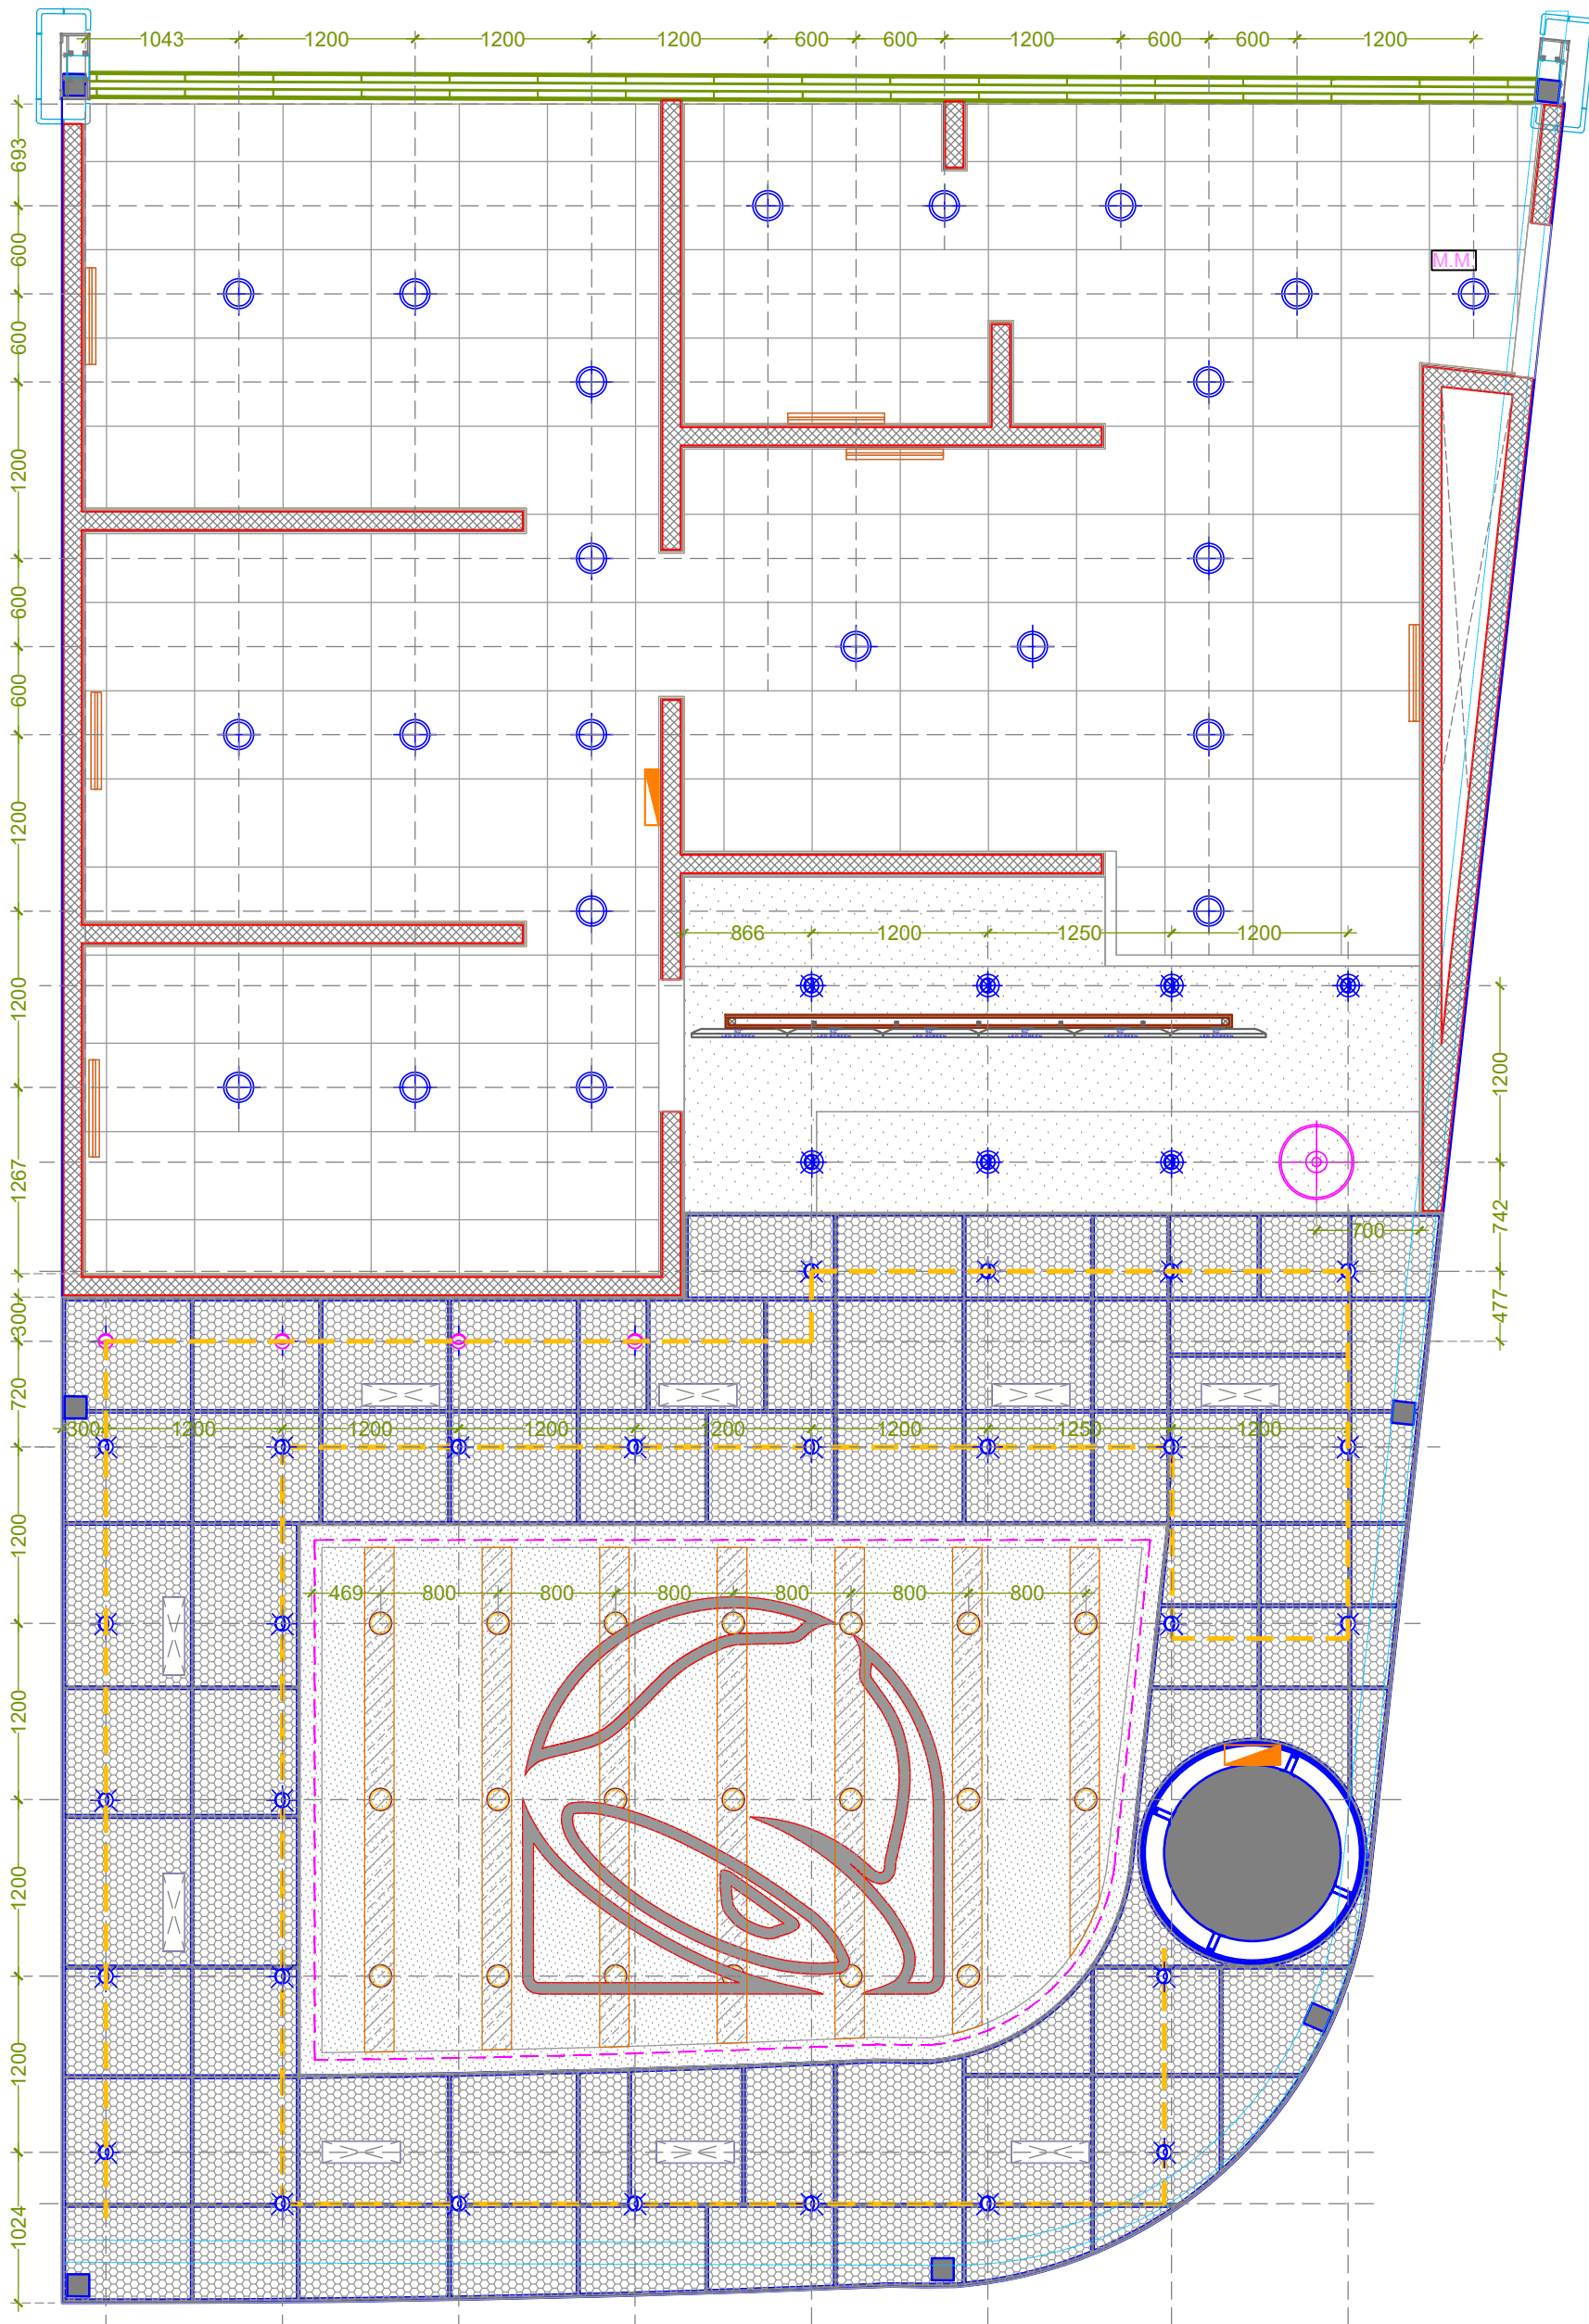

LEGEND	SIZE	LOCATION	SPECIFICATIONS	QTY.
	Ø1'-8"	COUNTER	MS DECORATIVE LIGHT HEIGHT 2'-4" FROM COUNTER TOP	01
	Ø8"	BOH AREA	ANKUR XRL - LED - IP9090 15W 6500K WHITE FINISH C/TOUT 152MM	22
		MOH AREA	ANKUR LANA XRL - LED - IP9493 12W 4000K RECESSED DOWN LIGHT WHITE FINISH Size: H 60MM x DIA 84MM x C/TOUT 73MM	07
		FOH AREA	ANKUR XSL - LED - 3945 GU10 SURFACE MOUNTED SPOT BLACK FINISH- Yellow LED 7W	04
		FOH AREA	LED STRIP LIGHT 4000K (22W PER MT.)	01
		BOH AREA	LED TUBE LIGHT IN BETWEEN FALSE CEILING & ROOF SLAB ON WALL	06
		FOH AREA	ANKUR XSL - LED - 3929 12W 3000K BLK Dimmable. HEIGHT SAME AS BOTTOM OF DUCT	28
		FOH AREA	Ankur Euro XRL-LED-IP9317 8W , COB LED Recessed Light 3000k Fixture Colour Black, with Chrome Reflector.	20