

PROJECT
AIRPORT,
DELHI

CLIENT
TACO BELL

NOTE:
THIS DRAWING & DESIGN IS THE COPYRIGHT OF THE DESIGNER. NO PORTION MAY BE REPRODUCED WITHOUT THE WRITTEN PERMISSION OF THE DESIGNERS

1. ALL DIMENSIONS ARE INCLUDING FINISHES
2. DO NOT SCALE DRAWING. ONLY MENTIONED DIMENSIONS ARE TO BE CONSIDERED.
3. ALL DIMENSIONS MUST BE CHECKED BEFORE COMMENCING WORK ON SITE.
4. ANY DISCREPANCIES SHALL BE BROUGHT UNDER THE NOTICE OF ARCHITECTS PRIOR COMMENCEMENT OF WORK.

CHECK POINTS:

- 1) ROUTING & SLOPE COSIDERED WITH RESPECT TO LEVEL RAISED.
- 2) LOCATIONS OF GRATING.
- 3) MAXIMUM THREE PIPES (INLET+OUTLET) IN ONE CHAMBER.
- 4) ROUTING OF PYTHON & ITS CROSSING WITH ANY OTHER DRAINAGE PIPE.
- 5) AVAILABLE DRAIN OUTLET INVERT LEVEL.
- 6) EXTERIOR PIPE TO BE LAID ALONG THE WALL IN DESIRED SLOPE.

REVISION

S.NO.	REMARKS	DATE
1	REV 1	00/00/00
2	REV 2	00/00/00
3	REV 3	00/00/00
4	REV 4	00/00/00
5	REV 5	00/00/00
6	REV 6	00/00/00
7	REV 7	00/00/00
8	REV 8	00/00/00

ARCHITECT / INTERIOR DESIGN

STUDIO
ARCHITECTURE PLANNING
INTERIOR DESIGN

FLAT NO-13 DDA SFS
SLAT POCKET -1 SEC-6 DWARKA,
NEW DELHI-110075
EMAIL:-info@stata@gmail.com
OFF-011-3559249,MOB-9910315171

CONSULTANT


CONSULTANT

RELEASE FOR

INFORMATION | TENDER | CONSTRUCTION | AS BUILT

TITLE
DRAINAGE LAYOUT

DATE	23-10-2023
SCALE	NTS
DRAWN BY	ANKITA
CHECKED BY	AR. ANKIT
PRINTED BY	-
DWG. NO.	WD-D-04 A

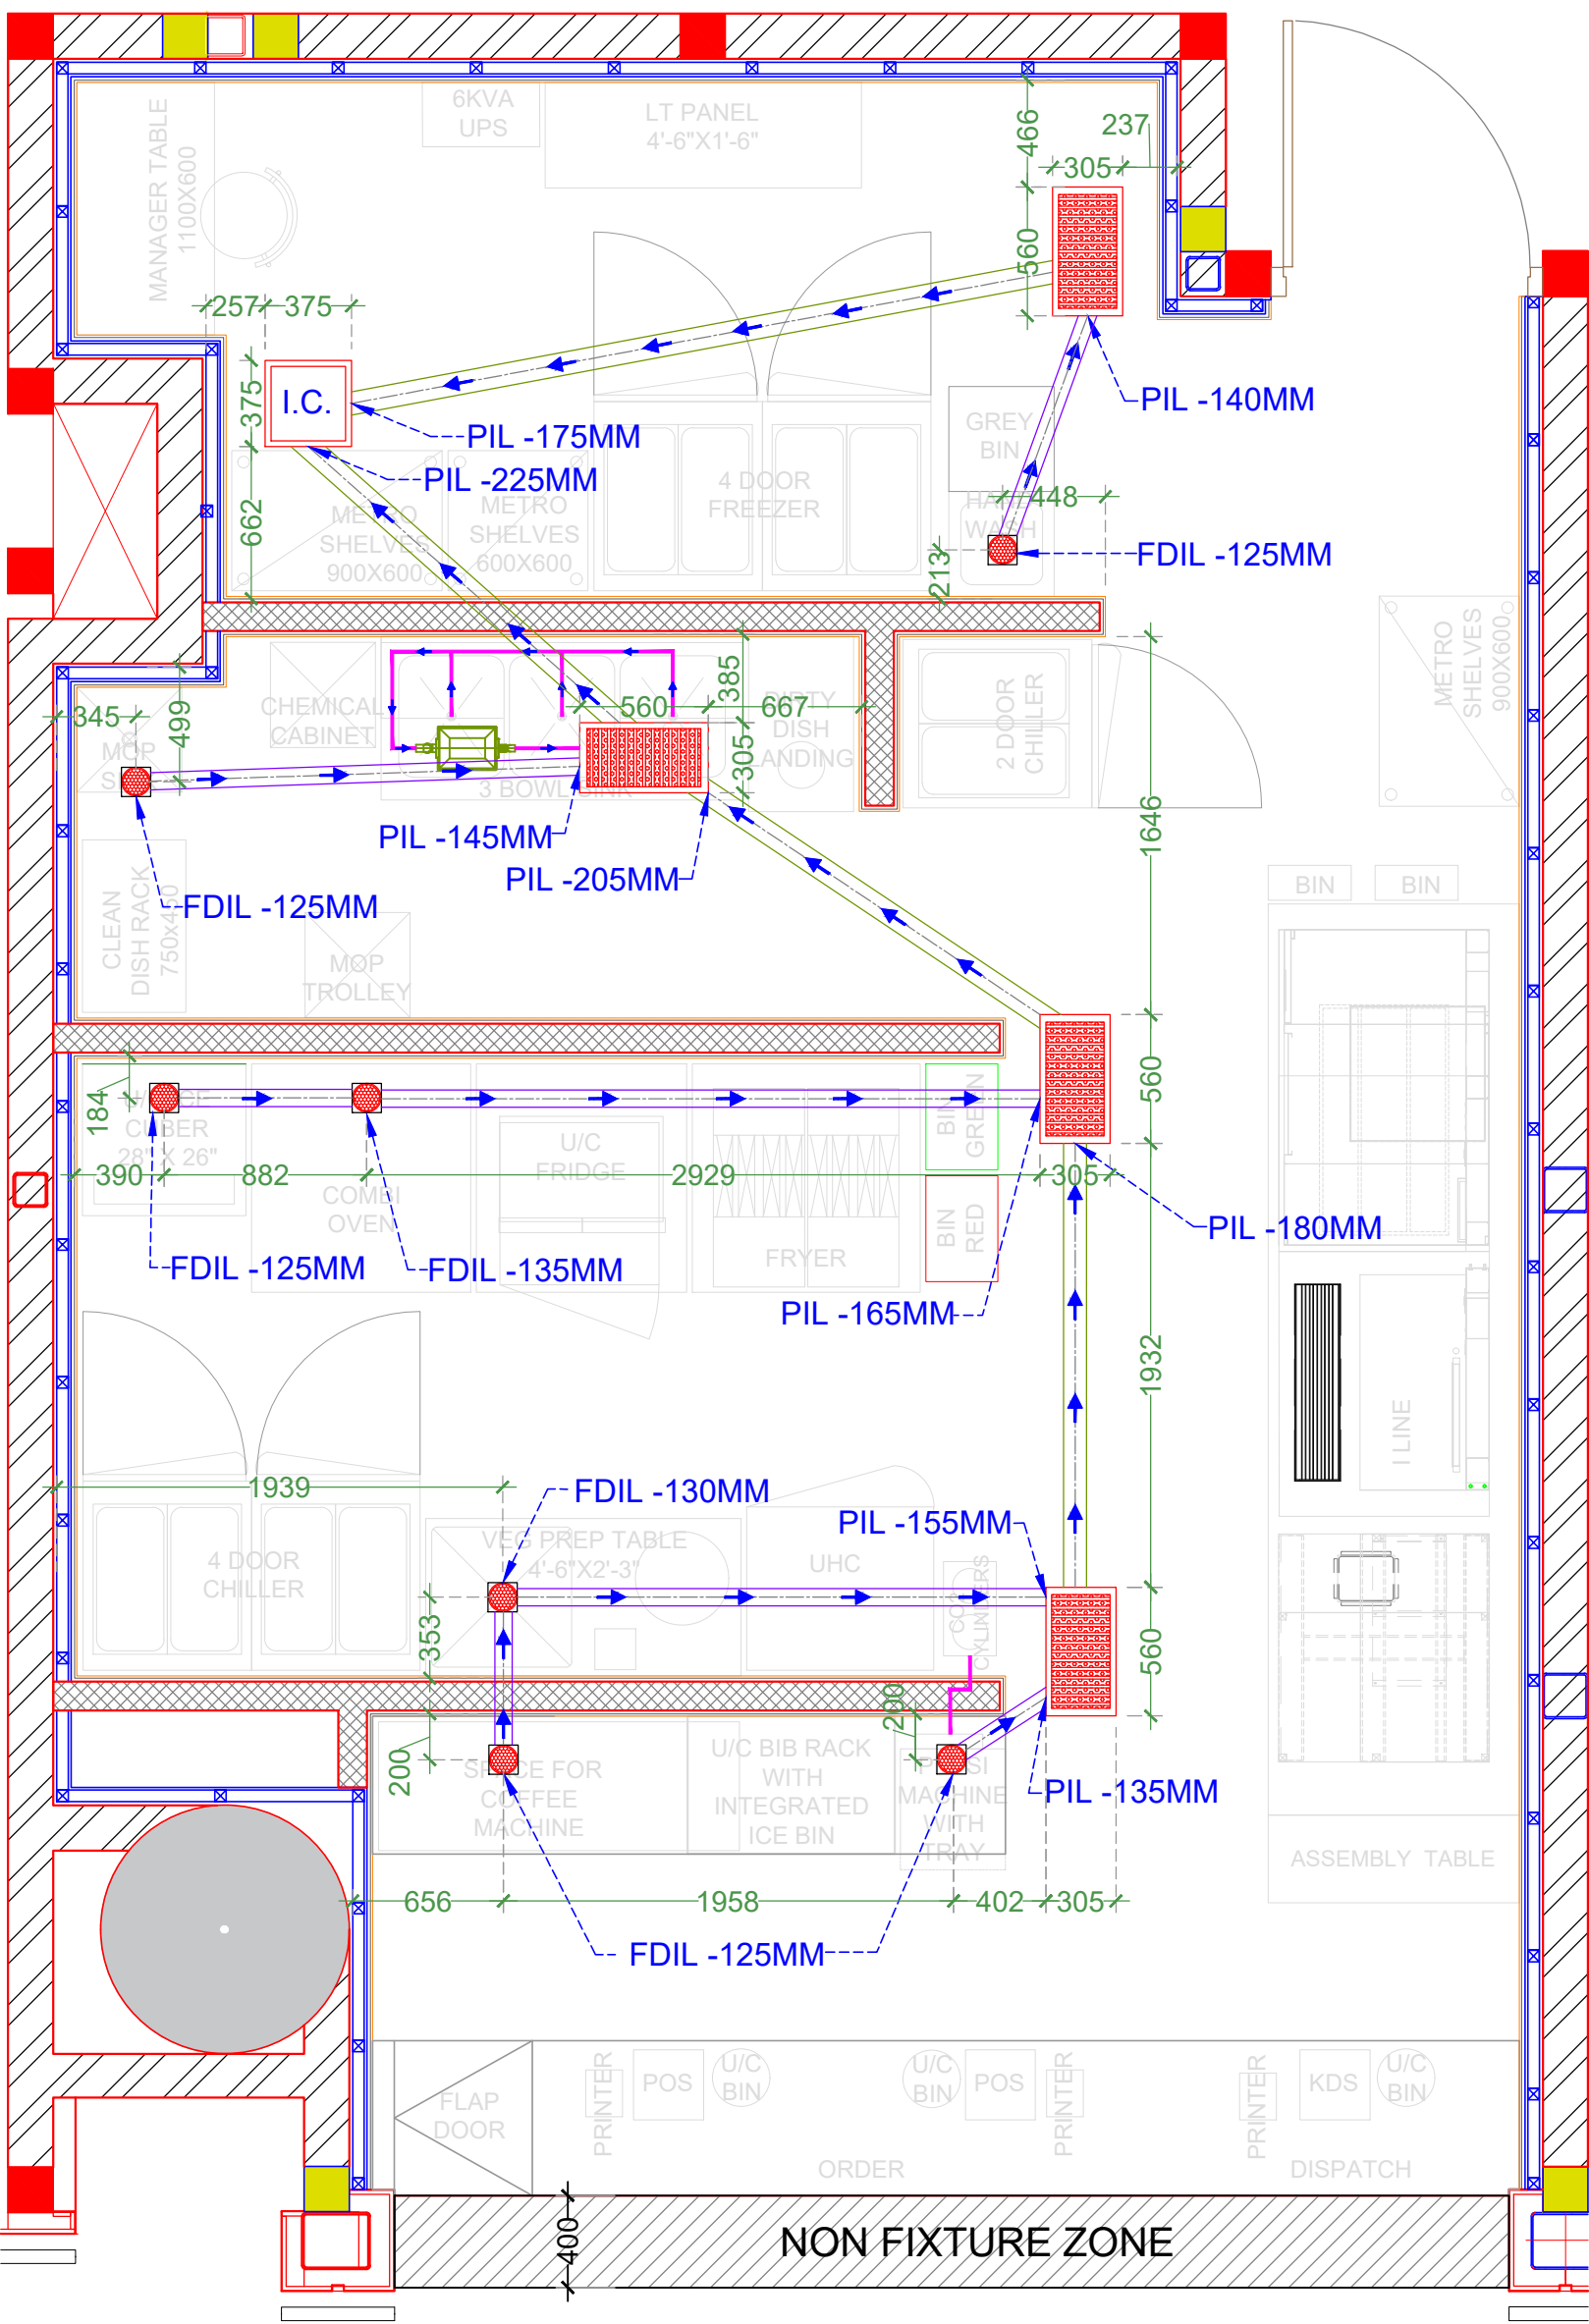

18MM THK. KOTA STONE FLOORING

SIPOREX FILLING (AS per SITE)

DRAIN/WASTE PIPE (DIA.AS/DRAINAGE ROUTING)

PIL AS/ SLOPE

P.C.C FOR SUPPORT THE DRAIN PIPE

3MM OR 4MM THICK PIDIFIN 2K, DR.FIXIT.

LEVELED RAW SLAB

TYPICAL SECTIONAL DRAIN PIPE DETAIL

DRAINAGE LEGEND

LEGEND	DESCRIPTION
	NAHANI TRAP
	SS GRATING 560MM X 300MM
	INSPECTION CHAMBER 375 X 375 MM WITH SS COVER
	160MM PIPE FOR BIB FLEXIBLE TUBE
	50MM PVC PIPES FOR
	50MM DIA PVC WASTE PIPE
	75MM DIA PVC WASTE PIPE
	100MM DIA PVC WASTE PIPE
	100MM DIA PVC SOIL WASTE PIPE
	PIL PIPE INVERT LEVEL
	FDIL FLOOR DRAIN INVERT LEVEL
	PORTABLE GREASE TRAP

NOTE: ALL PIPES SLOPE IS 1:100