



NOTE:REFER MEP DRAWING
FOR DETAIL DESIGN

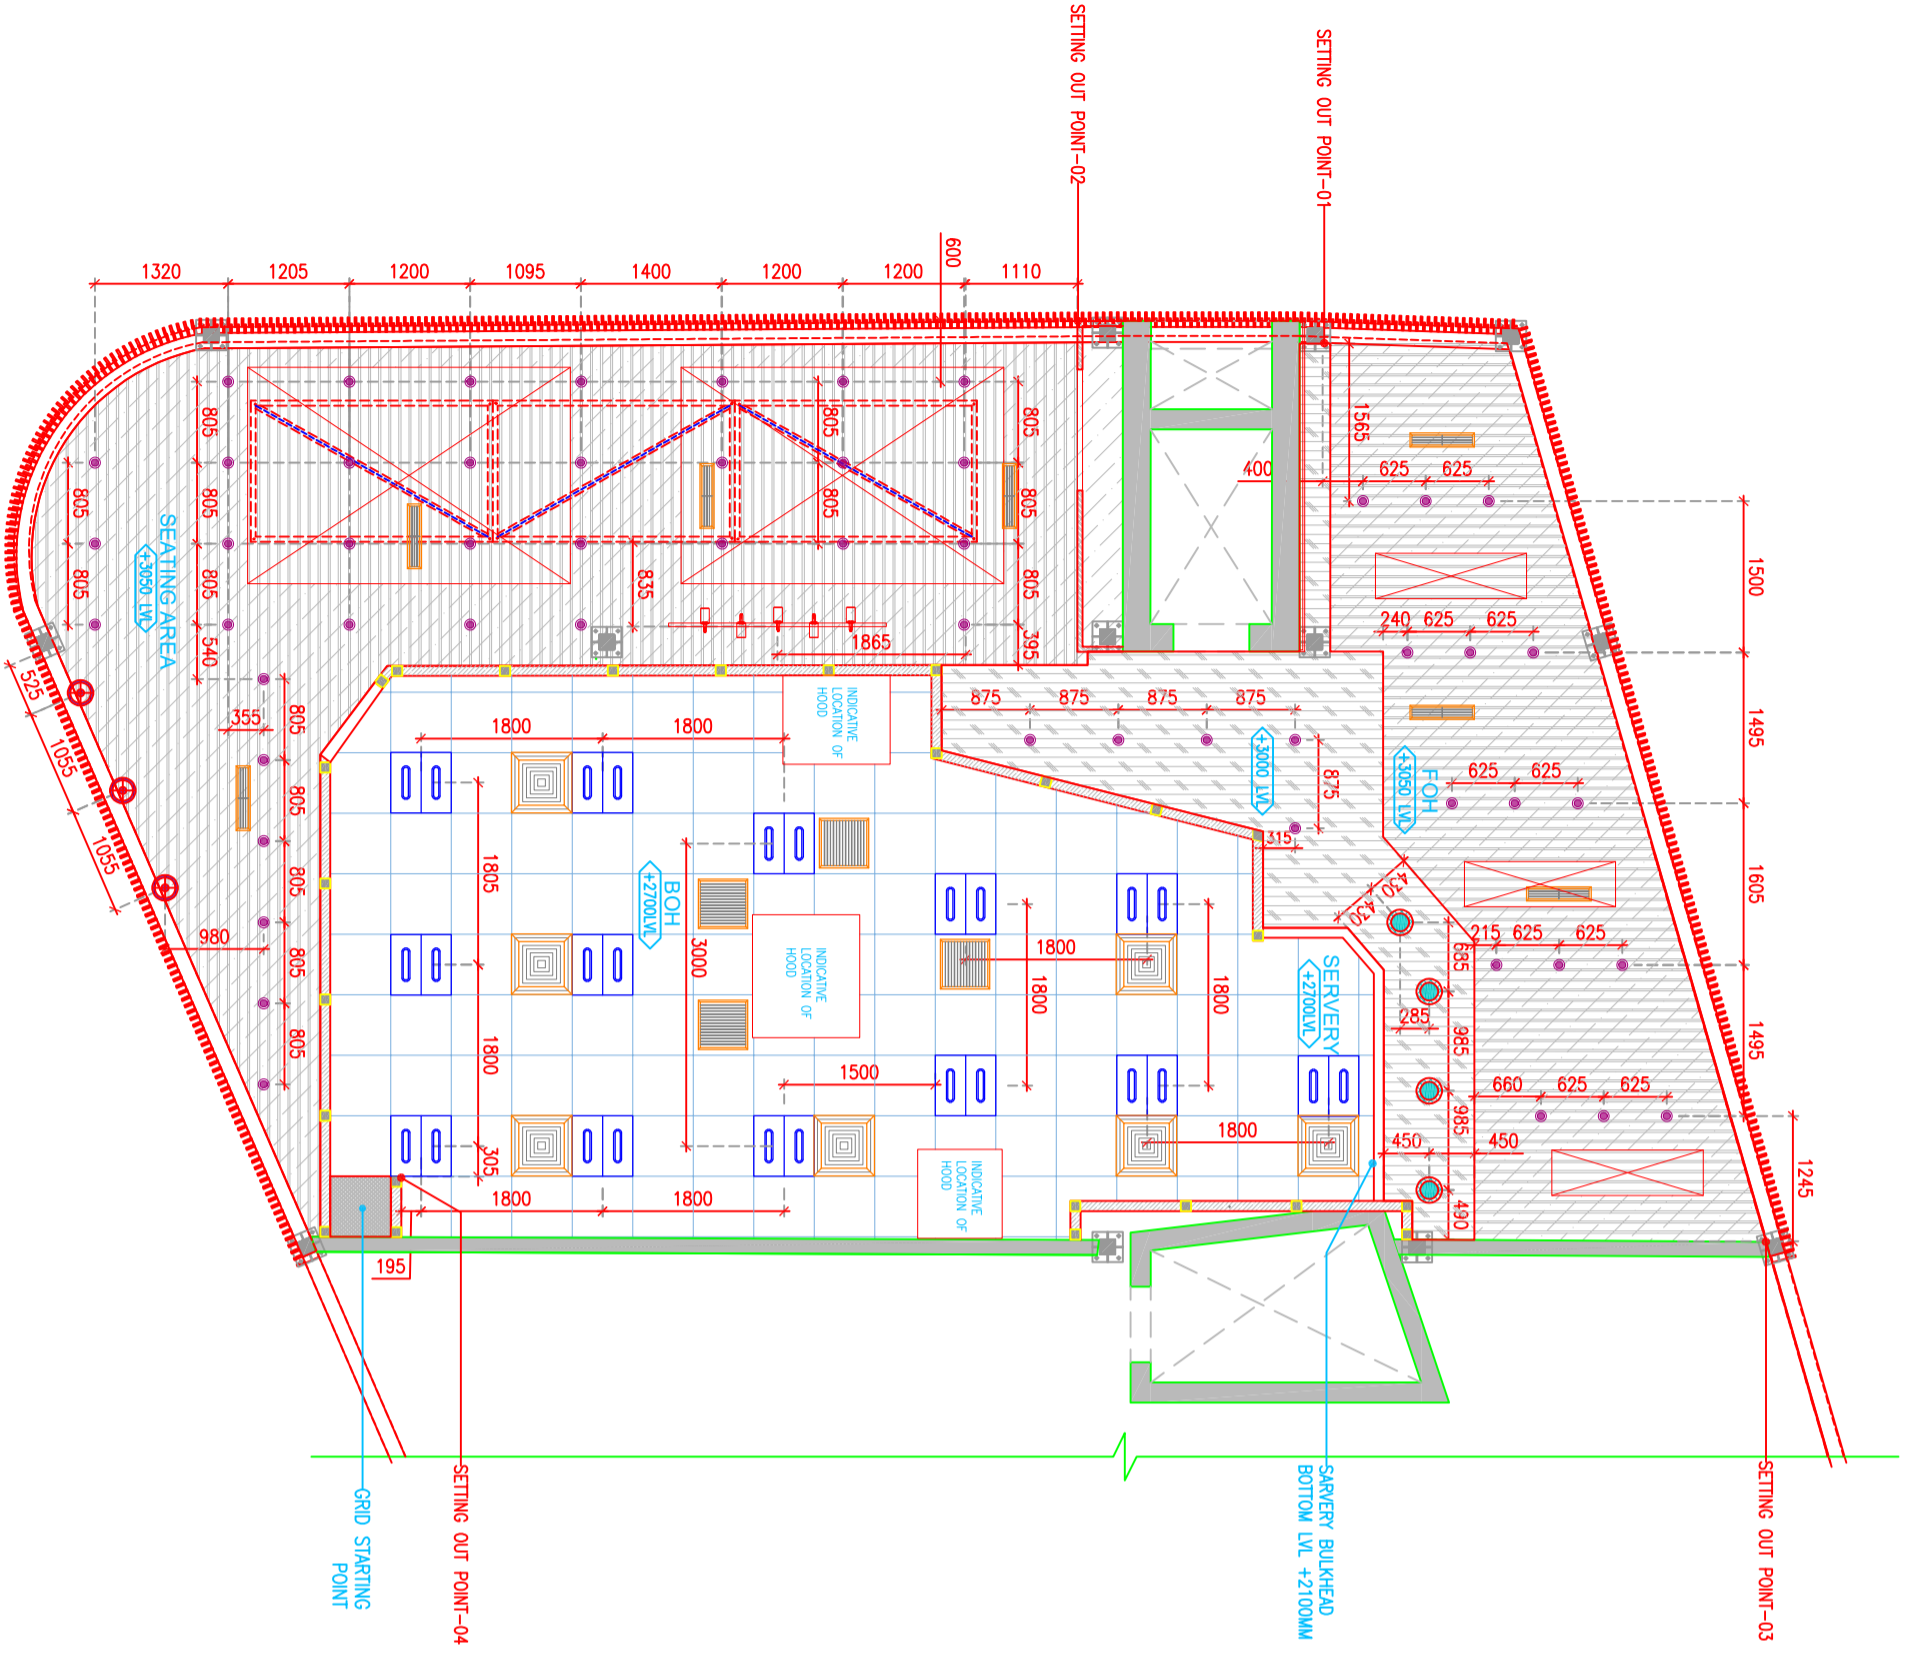

INDICATES ACMV FIXTURES

| LIGHTING LEGEND | | | |
|-----------------|--------|--|-------|
| CODE | SYMBOL | TYPE | NOS |
| LT01 | | CEILING LAMP TEMP:2700K | 04 |
| LT02 | | PENDANT LIGHT TEMP:2700K | 03 |
| LT03 | | DOWNLIGHT LIGHT TEMP:2700K | 55 |
| LT04 | | 600X600MM LED PANEL LIGHT TEMP:3000K | 13 |
| LT05 | | TRACK LIGHT LENGTH:2 M FINISH:BLACK | 01 |
| LT06 | | LED STRIP LIGHT TEMP:3000K | 8 Mtr |

001 03.06.24 TENDER
REV/ DATE DESCRIPTION
HNO NM
DRI OK

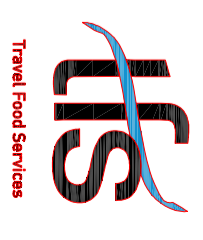

muffin
MUFFIN DESIGN SOLUTIONS, Villa F-7, NIT Andol
Vakasana, Sarippur, Bangalore, Karnataka, India.
T: +91 9841228255, www.muffin-d.com.

PROJECT
CARLSJUR FF018
GMR INTERNATIONAL
AIRPORT LIMITED,
HYDERABAD
DRAWING TITLE
LIGHTING LAYOUT & SCHEDULE

SCALE 1:75 DATE 03.05.2024 DRAWN HOD A3 SHEET

TENDER
PROJECT NO DRAWING TYPE NUMBER REV
TFS 0000 02GA 104BT01