

SUBWAY – FF 19



incUBIS[®]
ARCHITECTURE | INDUSTRIAL DESIGN | RETAIL PROJECTS







incUBIS[®]
ARCHITECTURE | INDUSTRIAL DESIGN | RETAIL PROJECTS












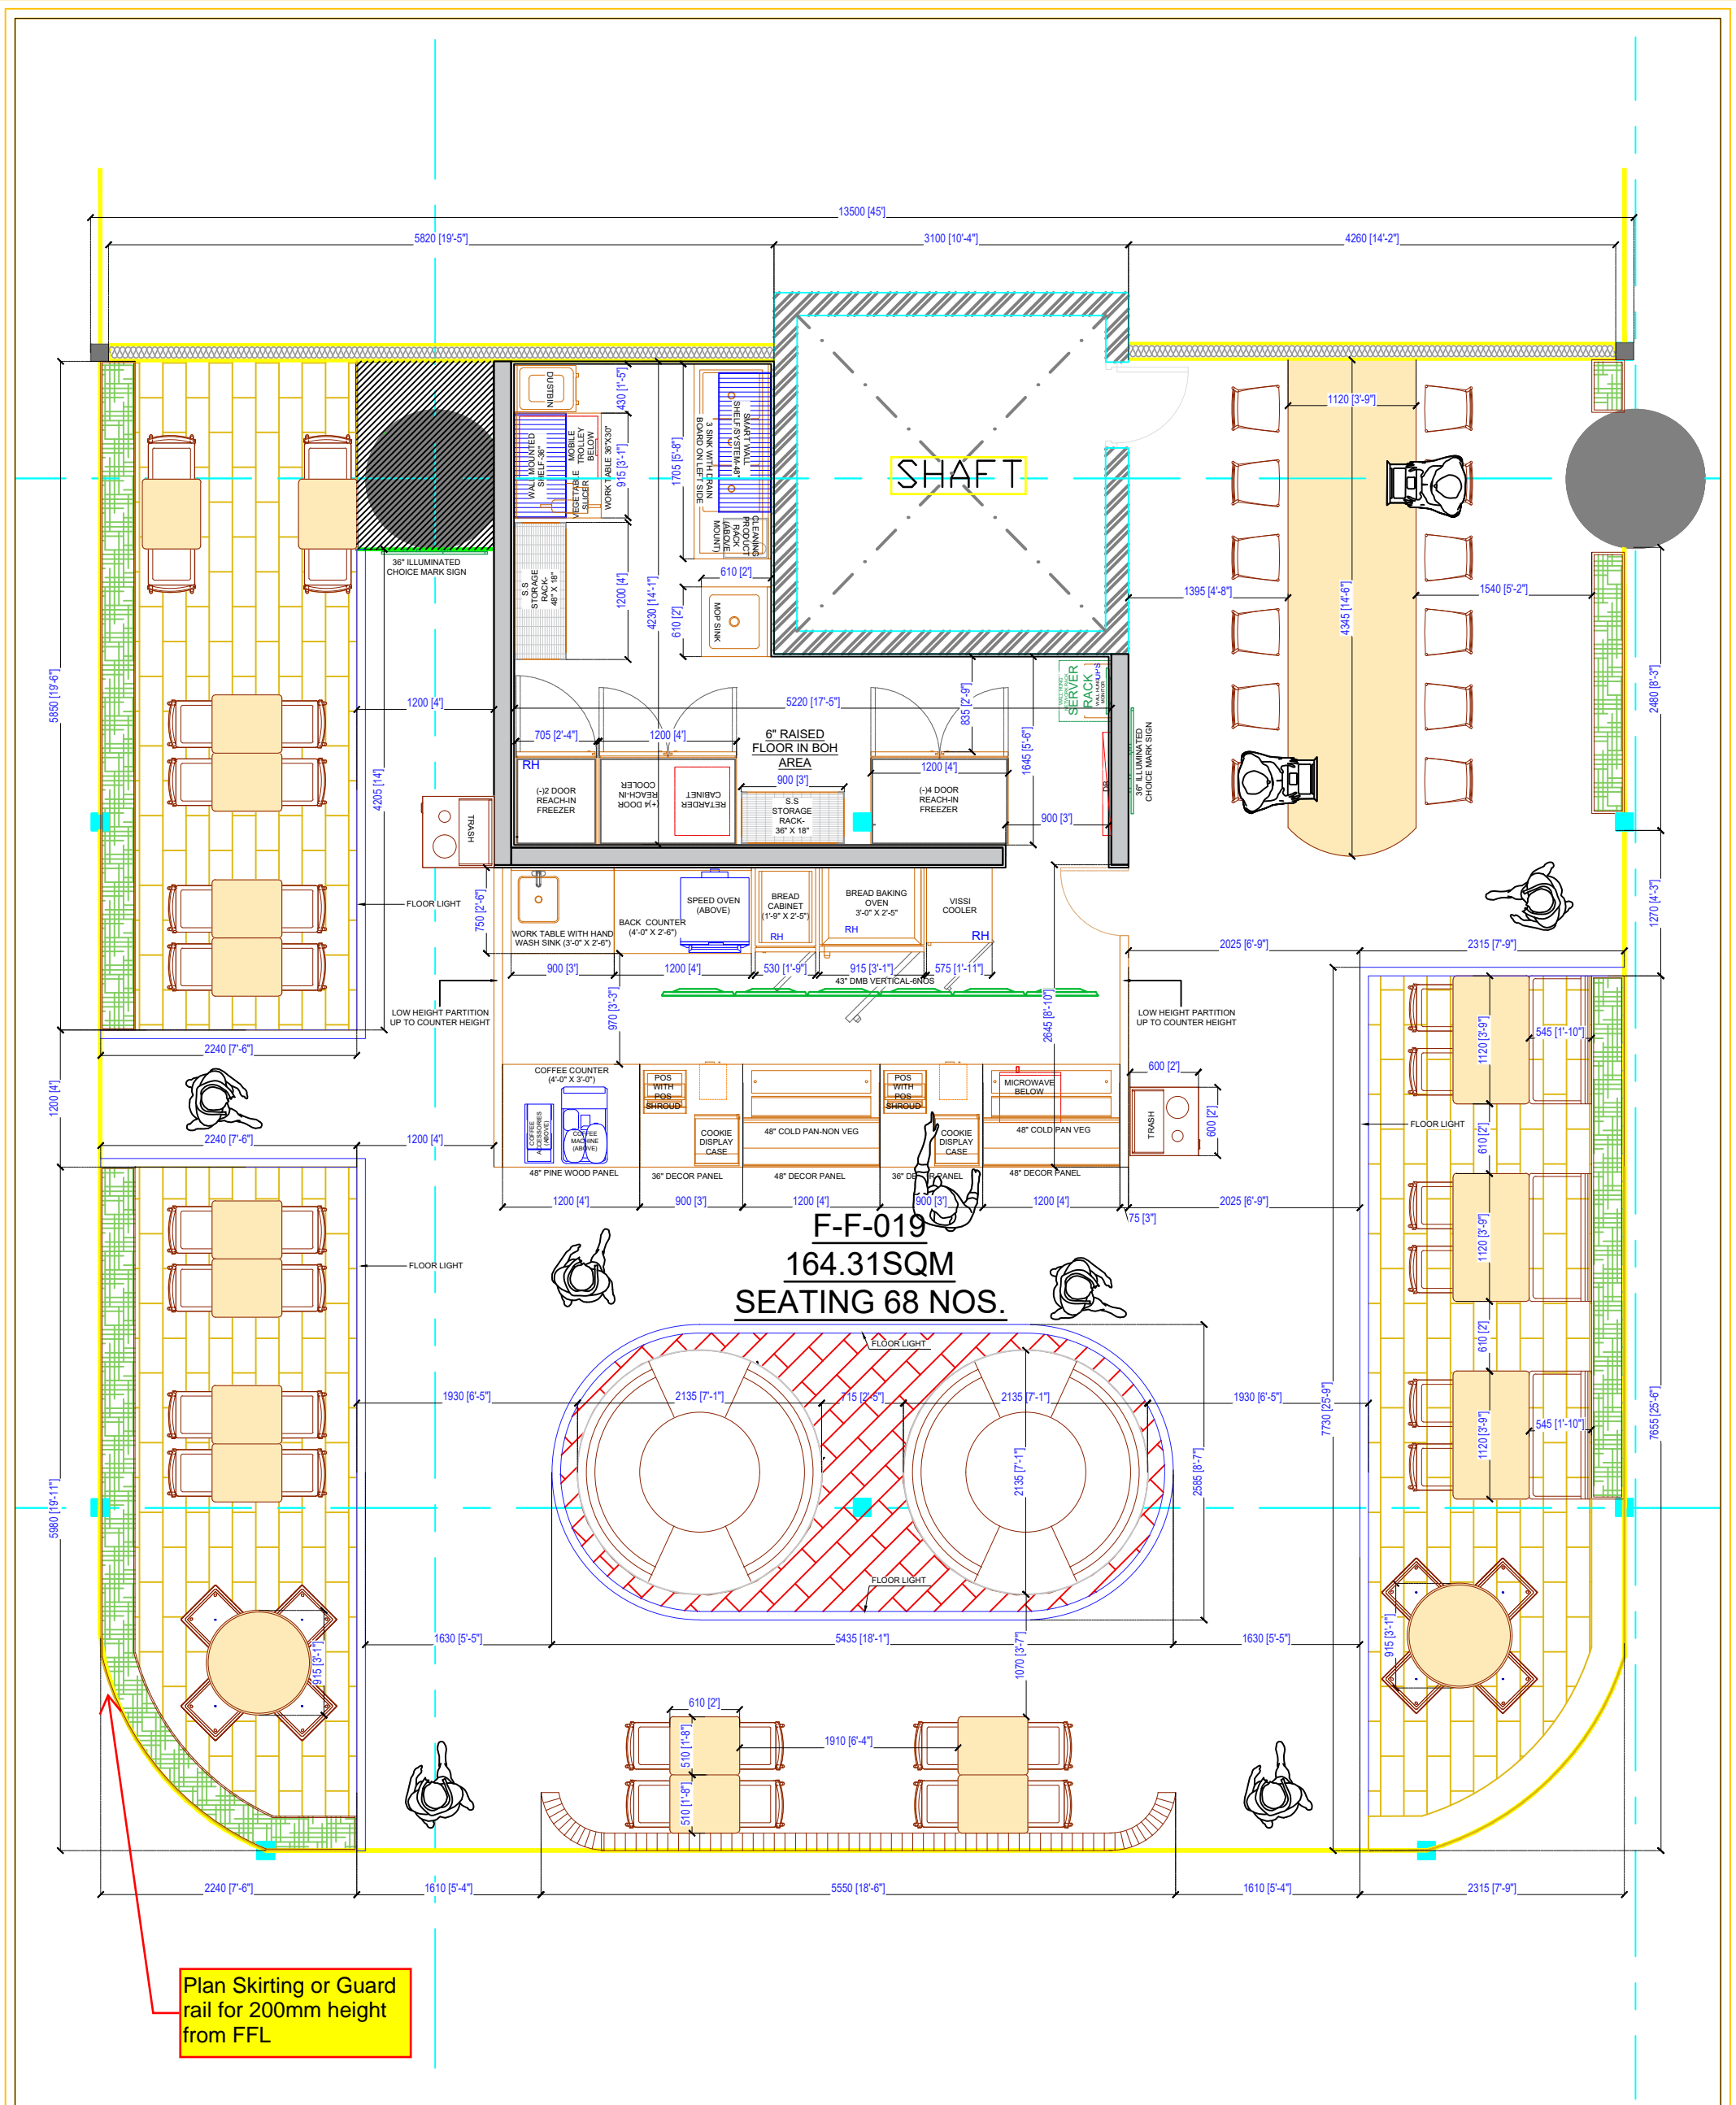

Plan Skirting or Guard rail for 200mm height from FFL

- * STORE FORMAT=AIRPORT KIOSK
- * CARPET AREA=164.31 SQM.
- * CUSTOMER AREA=130.88 SQM.
- * SERVICE AREA=13.43 SQM.
- * BOH AREA=20.00 SQM.
- * CEILING HT. (BOTTOM OF CEILING)=11'-2"
- * TOTAL SEATING=68 NOS.
- * DMB= 6 NOS. 43" SCREEN (VERTICAL) @6'-6" BOTTOM FROM CUSTOMER AREA F.FL

PLT-06
01 SCALE=NTS

SITE:
FF-19_HYDERABAD
AIRPORT
International-West


DRAWING TITLE:
EQUIPMENT & FURNITURE
LAYOUT, OPTION-6

MADE BY: AASTHA

DATE: 22th FEB 2024 **RD:** 01

SUBWAY
EVERSUB India Pvt Ltd

OFFICE :-
SUBWAY SYSTEMS INDIA PRIVATE
LIMITED,
Aurika Space Solutions, 3rd Floor, Tower-9,
Sriitech Cyber Park, Gurgaon, Haryana,
India-122002.

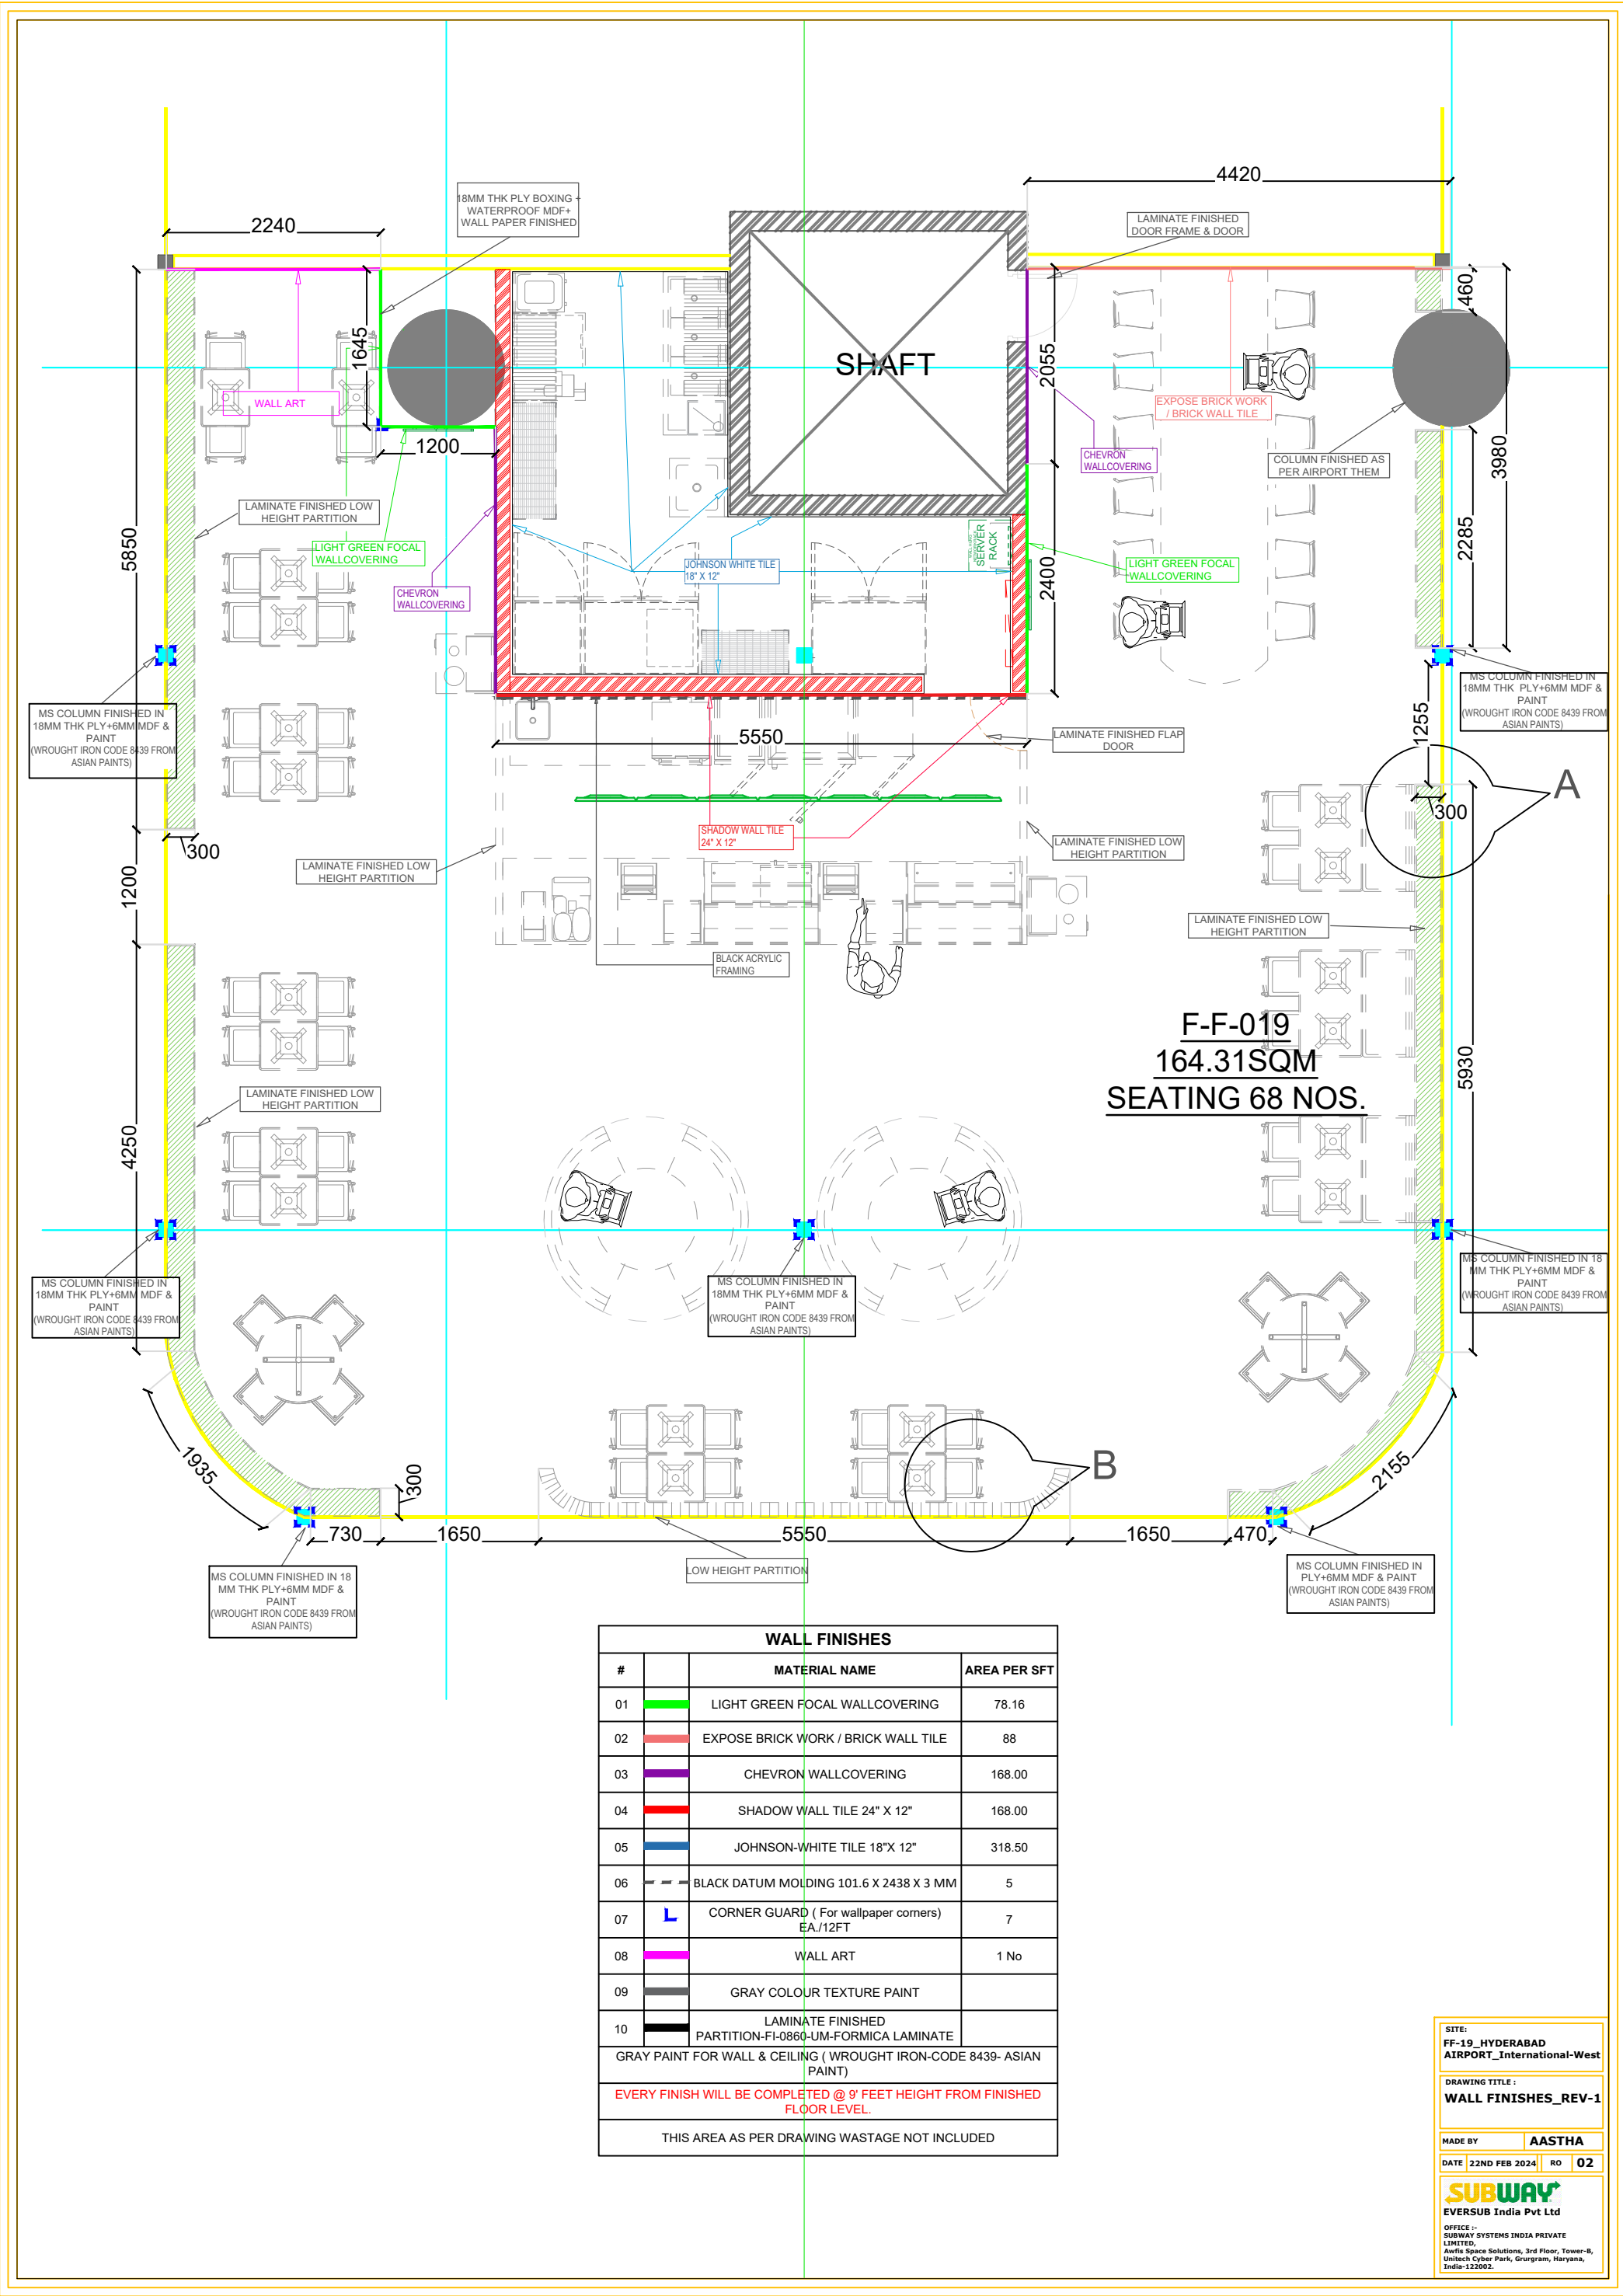

F-F-019
164.31SQM
SEATING 68 NOS.

WALL FINISHES		
#	MATERIAL NAME	AREA PER SFT
01	LIGHT GREEN FOCAL WALLCOVERING	78.16
02	EXPOSE BRICK WORK / BRICK WALL TILE	88
03	CHEVRON WALLCOVERING	168.00
04	SHADOW WALL TILE 24" X 12"	168.00
05	JOHNSON-WHITE TILE 18" X 12"	318.50
06	BLACK DATUM MOLDING 101.6 X 2438 X 3 MM	5
07	CORNER GUARD (For wallpaper corners) EA./12FT	7
08	WALL ART	1 No
09	GRAY COLOUR TEXTURE PAINT	
10	LAMINATE FINISHED PARTITION-FI-0860-UM-FORMICA LAMINATE	
GRAY PAINT FOR WALL & CEILING (WROUGHT IRON-CODE 8439- ASIAN PAINT)		
EVERY FINISH WILL BE COMPLETED @ 9' FEET HEIGHT FROM FINISHED FLOOR LEVEL.		
THIS AREA AS PER DRAWING WASTAGE NOT INCLUDED		

SITE:
FF-19_HYDERABAD
AIRPORT_International-West


DRAWING TITLE:
WALL FINISHES_REV-1

MADE BY: **AASTHA**




DATE: **22ND FEB 2024** | RO: **02**

SUBWAY
EVERSUB India Pvt Ltd

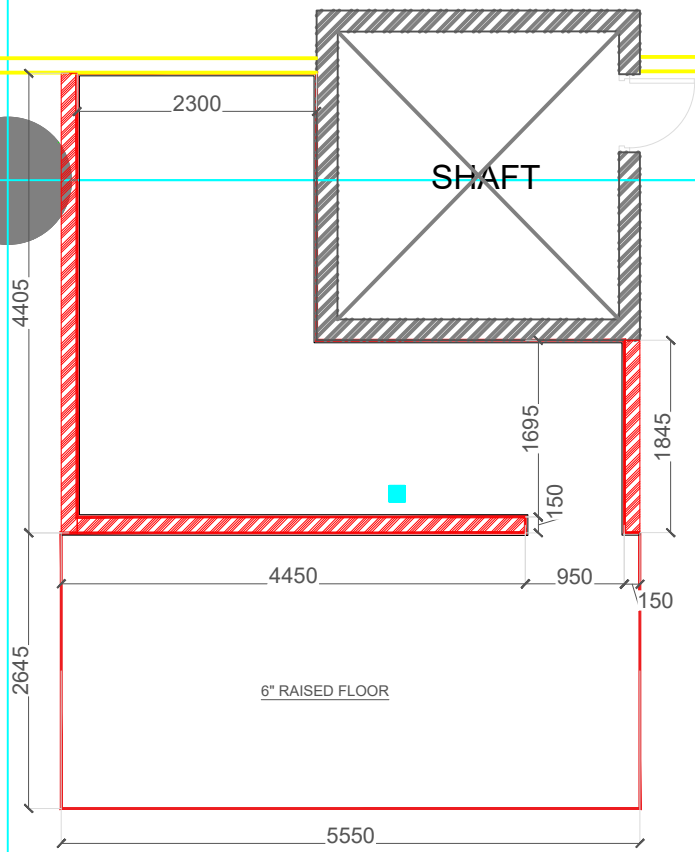OFFICE :-
 SUBWAY SYSTEMS INDIA PRIVATE LIMITED,
 Awta Space Solutions, 3rd Floor, Tower-8,
 Unitech Cyber Park, Grurgram, Haryana,
 India-122002.



F-F-019
164.31SQM
SEATING 68 NOS.

CIVIL LEGEND		
SYMBOL	DESCRIPTION	QTY IN SQ FT
	EXISTING BRICK WALL	
	BRICK WALL WITH PLASTER 12' HEIGHT	480
	BRICK WALL WITH PLASTER	

NOTE:

- PLEASE REFER PLUMBING & DUCTING LAYOUT FOR HEIGHT
- ALL HEIGHT ARE FROM FINISH FLOOR LEVEL

SITE:
FF-19_HYDERABAD
AIRPORT_International-West


DRAWING TITLE :
CIVIL LAYOUT

MADE BY AASTHA

DATE 05-01-24 **RO** 02

SUBWAY
EVERSUB India Pvt Ltd


OFFICE :
EVERSUB SYSTEMS INDIA PRIVATE
LIMITED,
Aurilla Space Solutions, 3rd Floor, Tower-B,
Umlesh Cyber Park, Gurugram, Haryana,
India-122002.

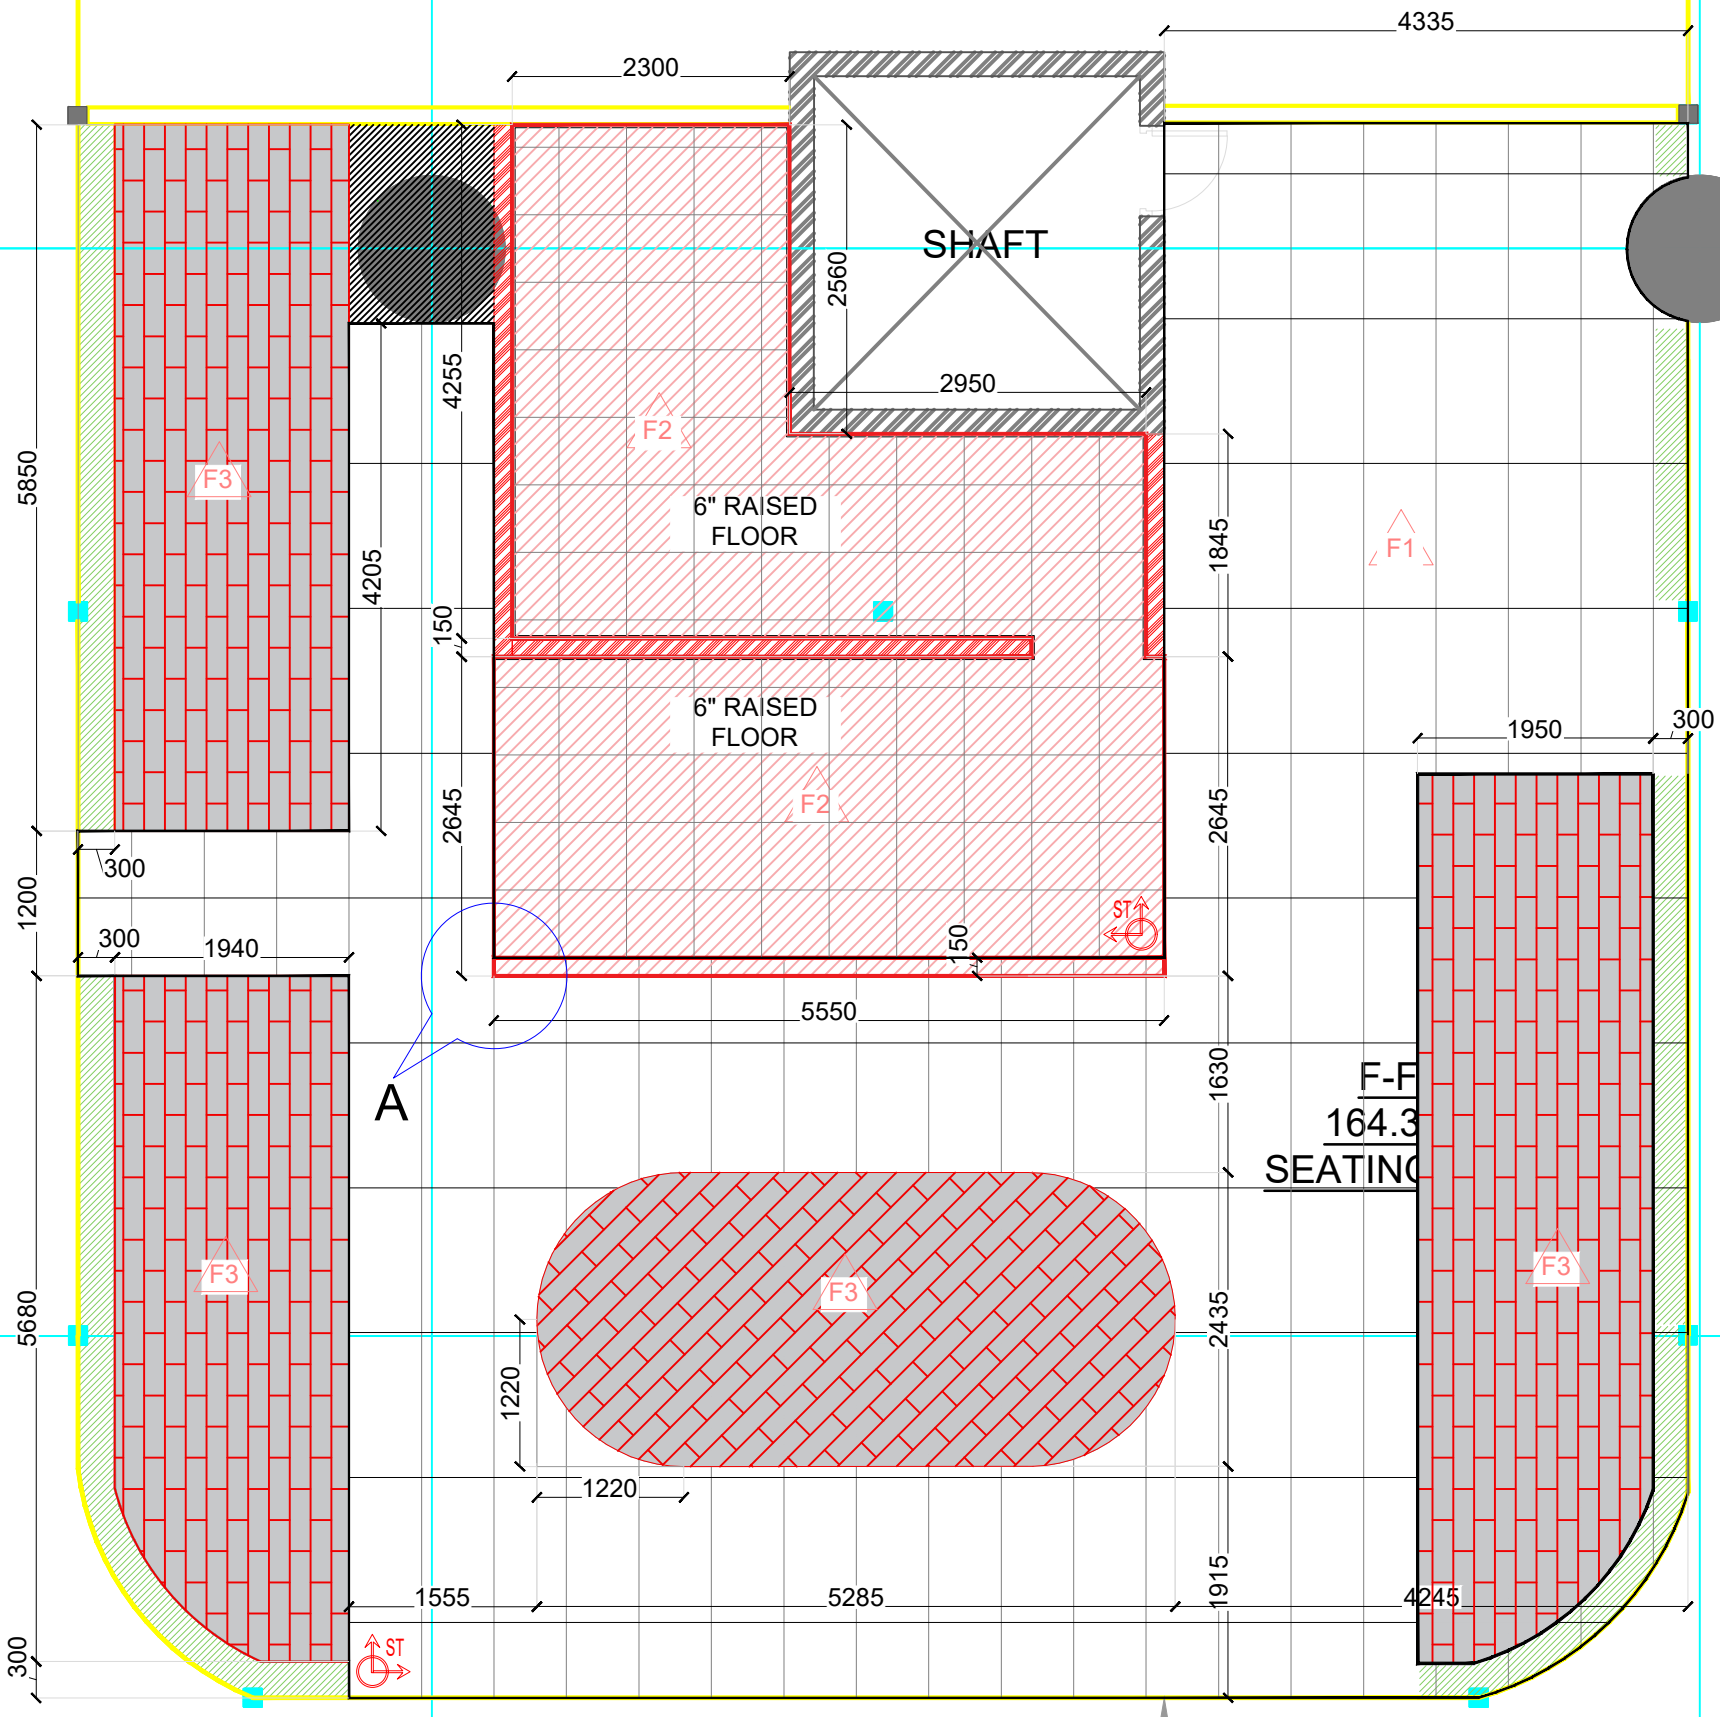


A

F-F
164.3
SEATING

FLOOR SCHEDULE				
NOTE: THE SUBWAY STORE DESIGN DEPARTMENT WILL NOT ACCEPT RESPONSIBILITY FOR ANY INACCURACIES. THE CALCULATIONS PROVIDED BELOW MUST BE VERIFIED BY THE G.C. AND FRANCHISE OWNER BEFORE ANY ORDER FOR THESE MATERIALS IS ACCEPTED AND PLACED.				
IMAGE	SYMBOL	ROOM	MATERIAL	AREA IN SFT.
	F2	SERVICE AREA / BOH	POLISHED KOTA STONE 22" X 22"	366.00
	F3	WOODEN FLOOR	WOODEN FLOORING (CLASSIC OAK - 1200 MM X 200 MM) MAKE JOHNSON	900.00
	F1	CUSTOMER AREA 1	TERRAZZO GRAY - 1200 MM X 600 MM (MAKE-KAJARIA)	1250
RAISED FLOOR IN BOH AREA & SERVICES AREA				
15% SKIRTING & WASTAGE INCLUDED IN THIS AREA				

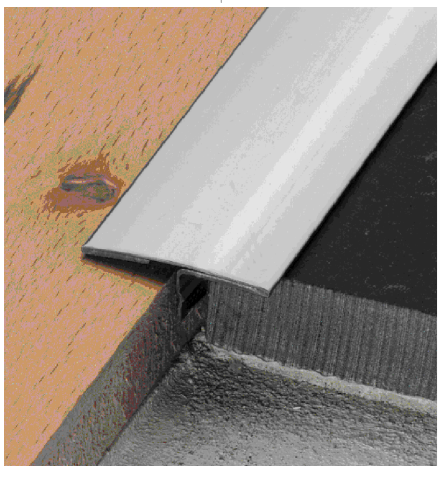

6MM S.S TRANSITION STRIP TO BE ADDED AT THE ENTRANCE TO SEPARATE THE AIRPORT'S FLOORING FROM THE SUBWAY FLOORING

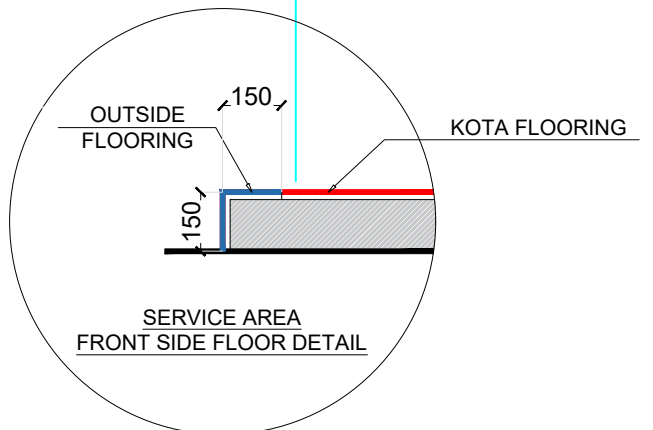

DETAIL-A

SITE:
FF-19_HYDERABAD
AIRPORT_International-West


DRAWING TITLE:
FLOORING
LAYOUT_REV-1




MADE BY: AASTHA

DATE: 22-02-24 RD: 02

SUBWAY
EVERSUB India Pvt Ltd

OFFICE :-
SUBWAY SYSTEMS INDIA PRIVATE
LIMITED,
Awfis Space Solutions, 3rd Floor, Tower-9,
Ghitich Cyber Park, Gurgaon, Haryana,
India-122002.

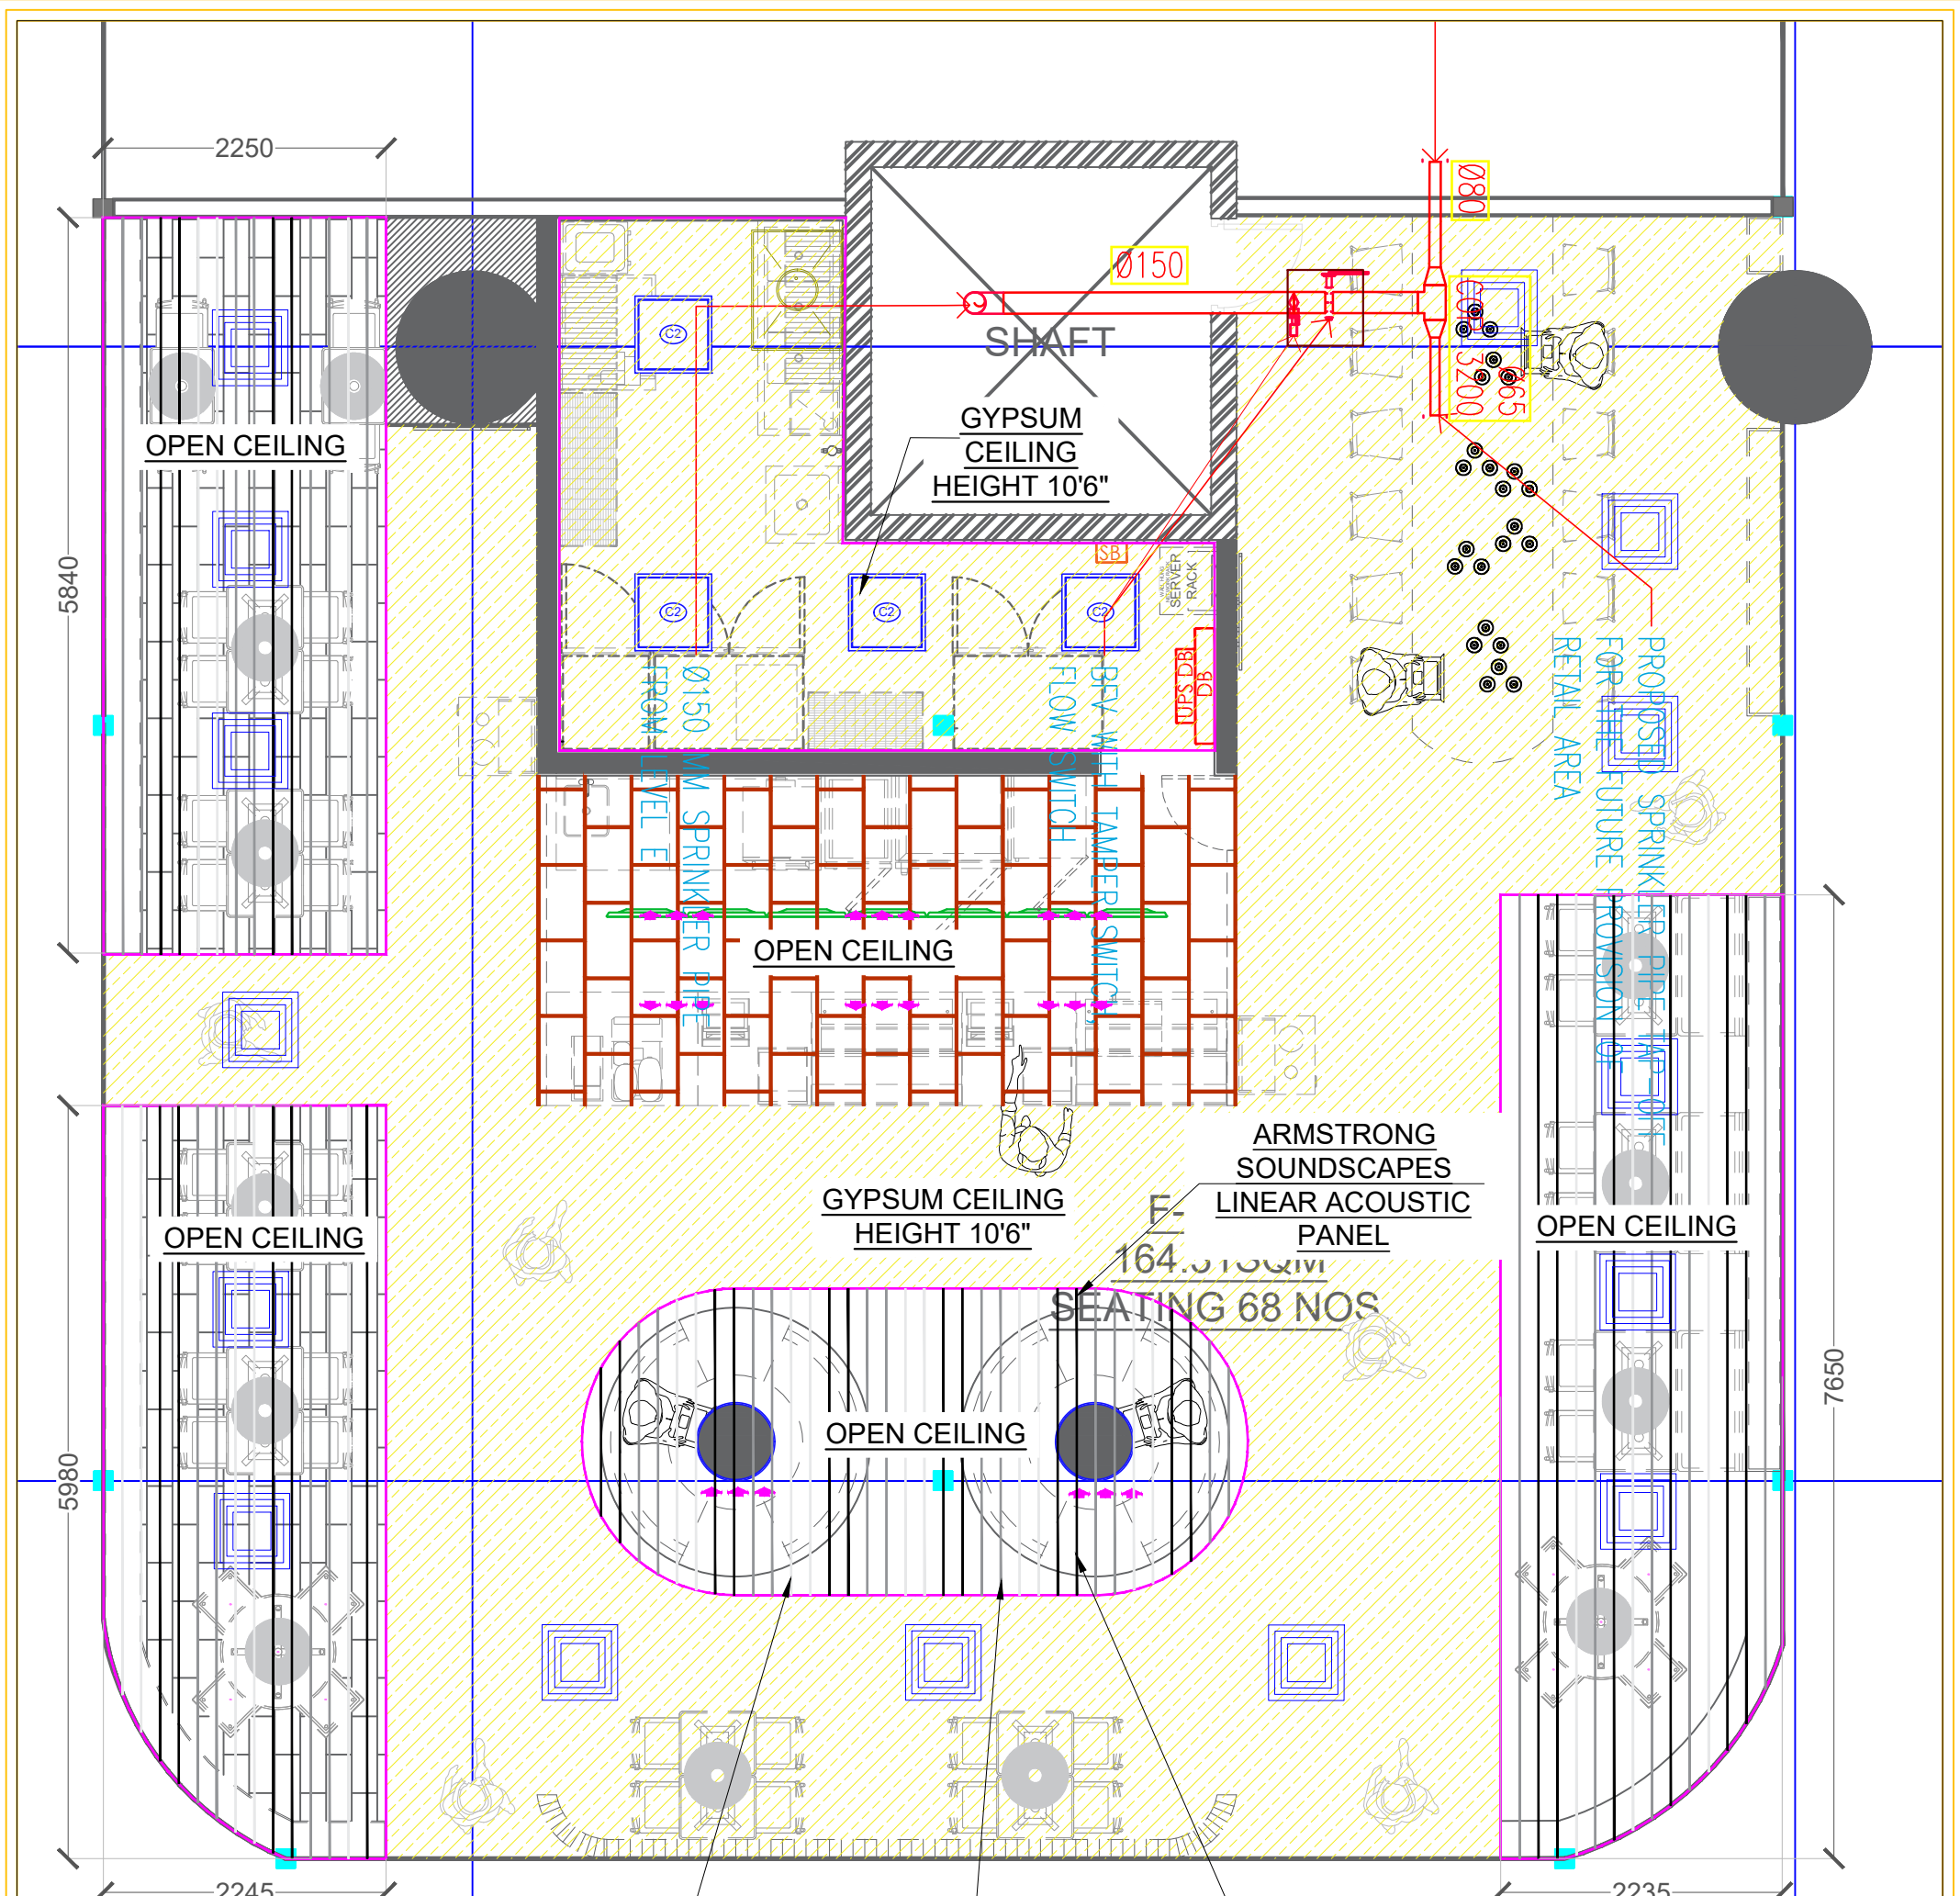


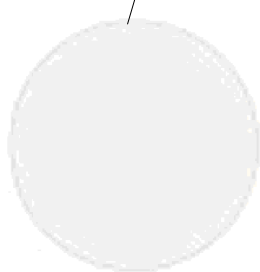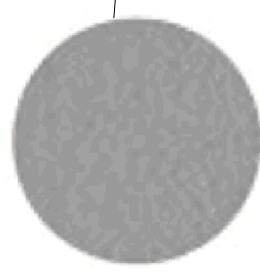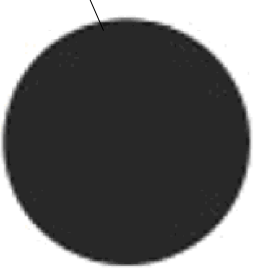- 
 White
(WH)
- 
 Stone
(SE)
- 
 Black
(BK)



REFERENCE IMAGE
FOR ARMSTRONG
CEILING

SITE: FF-19_HYDERABAD AIRPORT_International-West	
DRAWING TITLE: CEILING LAYOUT	
MADE BY	AASTHA
DATE	13TH FEB 2024 RO 07
 EVERSUB India Pvt Ltd	
OFFICE :- SUBWAY SYSTEMS INDIA PRIVATE LIMITED, Awlis Space Solutions, 3rd Floor, Tower-9, Unitech Cyber Park, Gurgaon, Haryana, India-122002.	

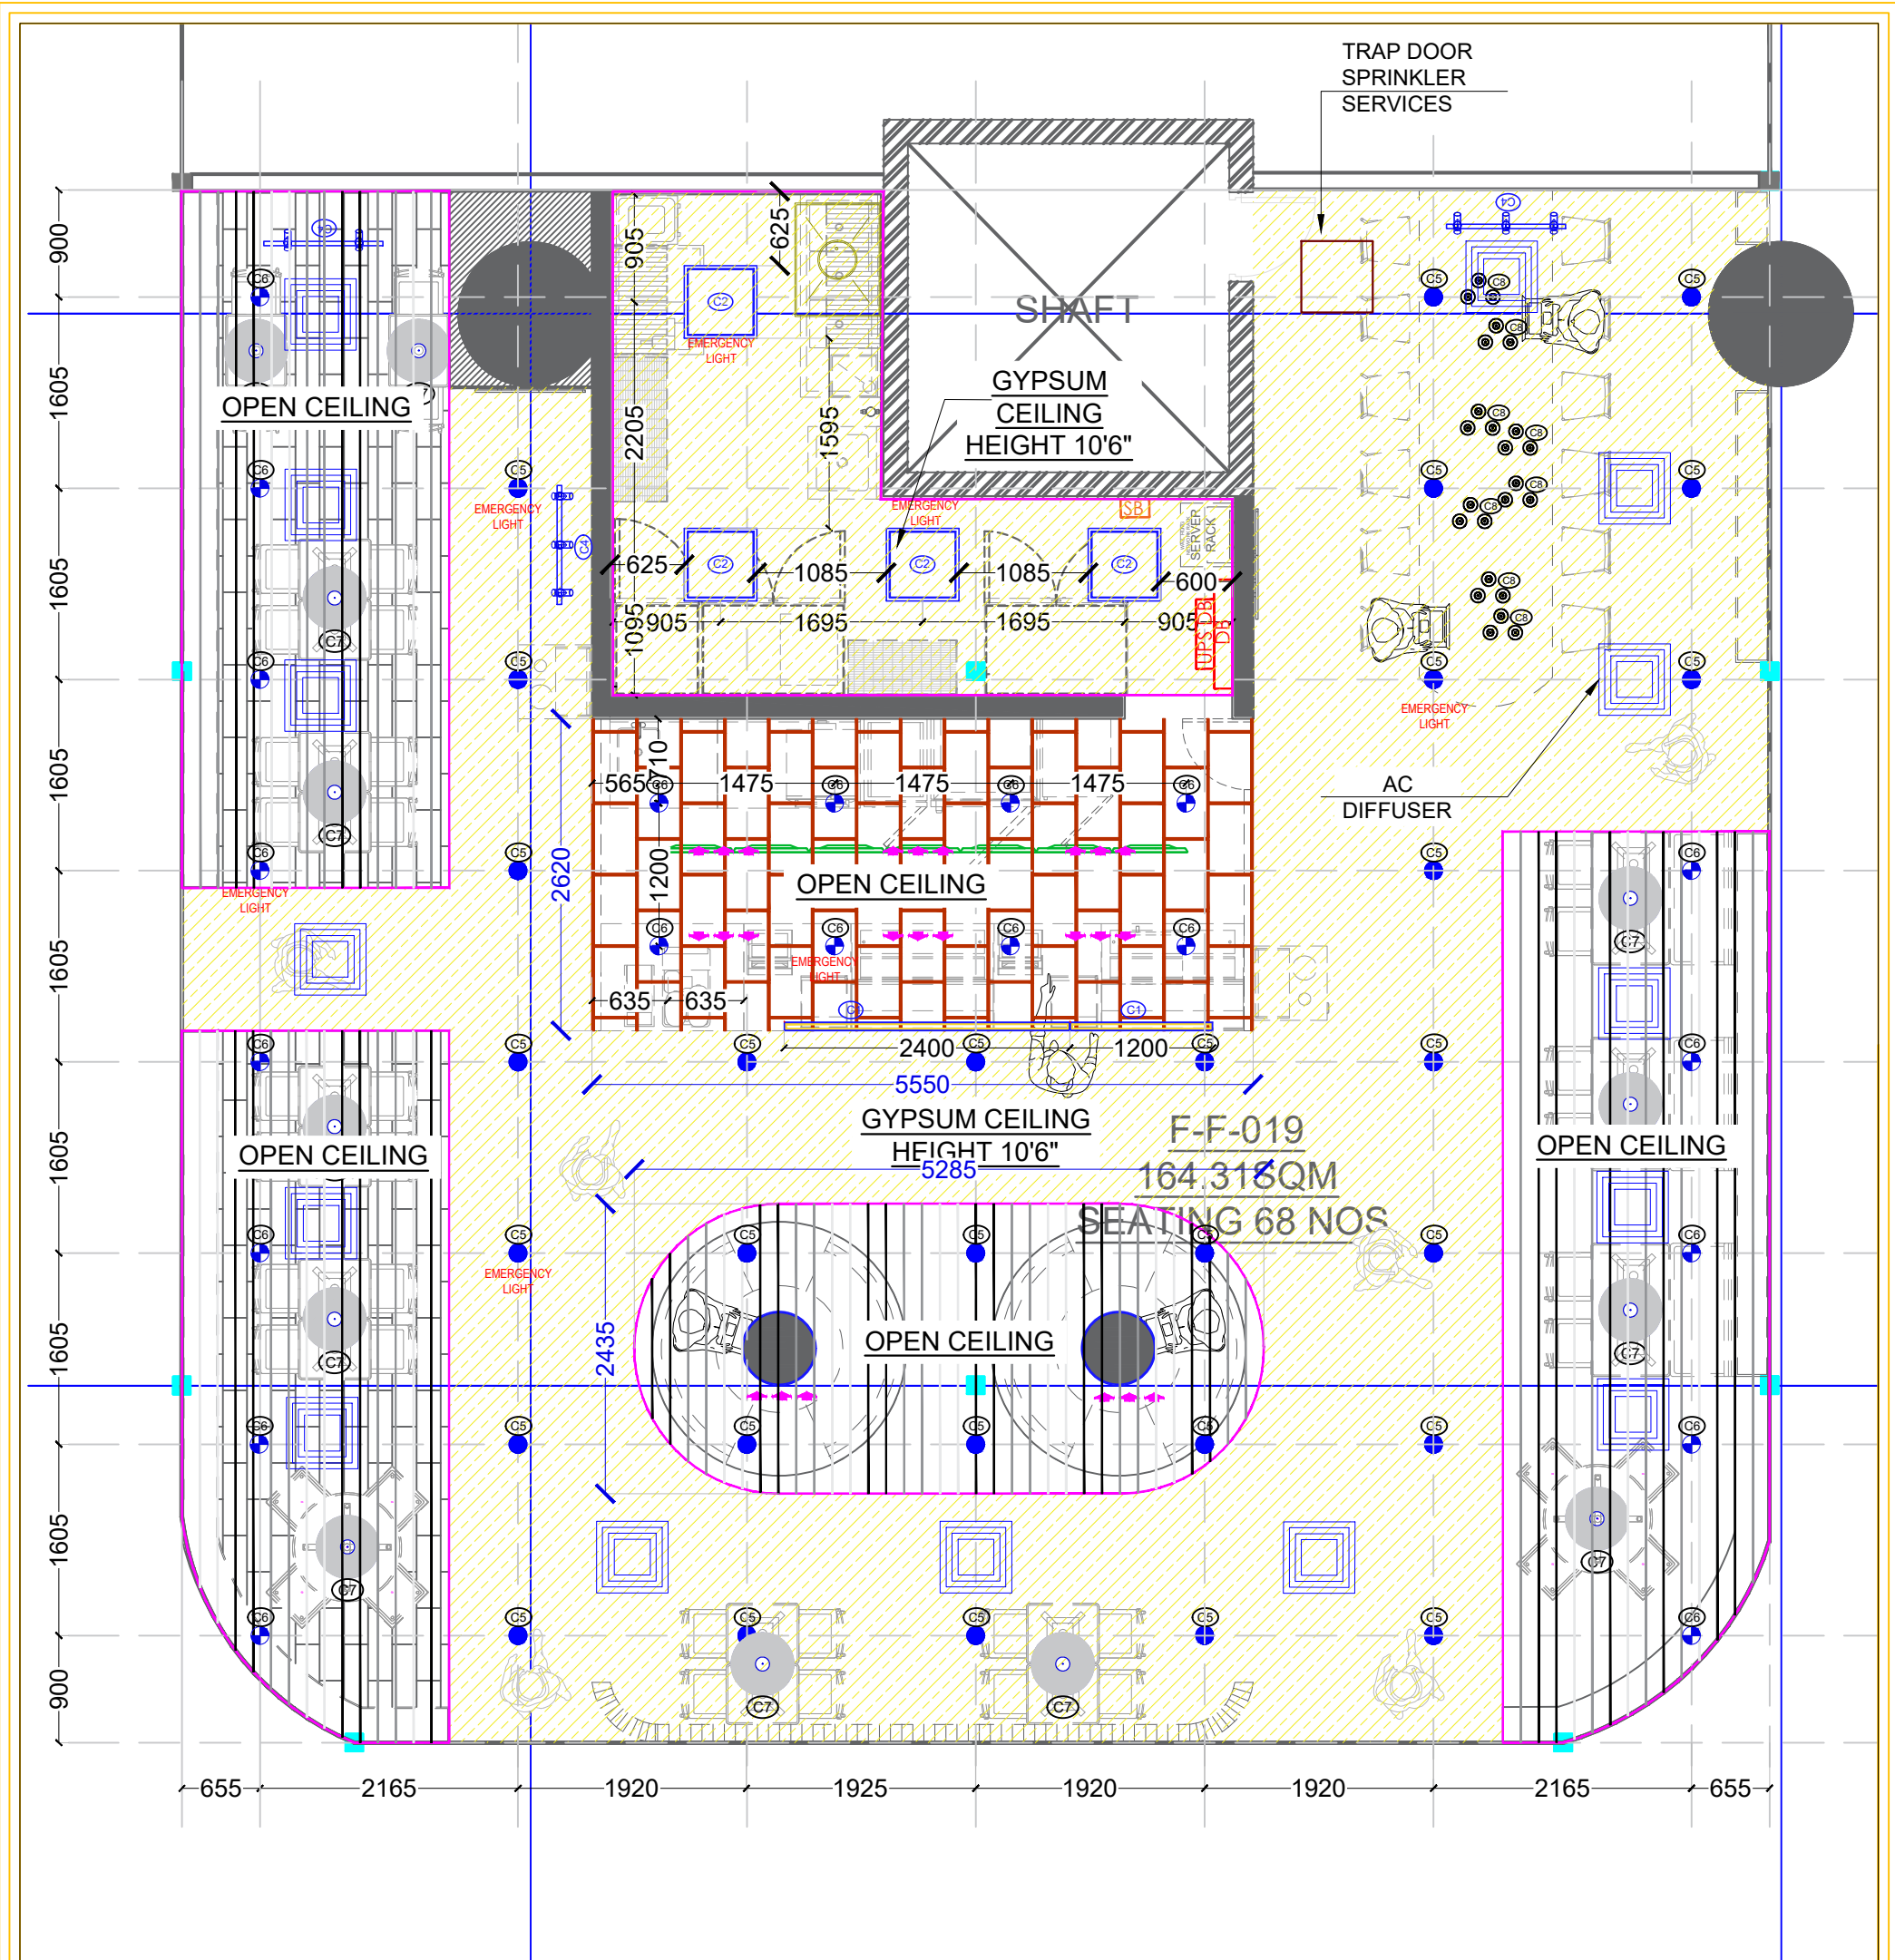

CEILING FIXTURE AND LIGHTING SCHEDULE						
IMAGE	#	MODEL	COUNT	DESCRIPTION	WATTAGE	TOTAL WATTS
	C1	SUSPENDE LINEAR CHANNEL LIGHT	1	8' LENGTHS, 72 W, JOINTER & ADDITIONAL STRING REQUIRE (HEIGHT 7' FROM LIGHT TO SLAB)	72	2153
	C1	SUSPENDE LINEAR CHANNEL LIGHT	1	4' LENGTHS, 36 W, JOINTER & ADDITIONAL STRING REQUIRE (HEIGHT 7' FROM LIGHT TO SLAB)	36	
	C2	595X595 MM CEILING LED LIGHT	4	CEILING 38 W LEDLIGHT. 10W, 220-240V, 4000K, 3900 LUMEN OUTPUT.	152	
	C6	Vertica LED	27	WATTAGE 30 W, ALUMINIUM BODY POWDER COATED IN BLACK, CLEAN DIFFUSER, HIGH POWER HIGH LUMEN OUTPUT LED, HIGH EFFICIENCY REFLECTOR OPTICS, EFFECTIVE THERMAL MANAGEMENT	810	
	C4	MINI TL 2 LINE	8	WATTAGE 15W , CCT 3K, LIGHT SOURCE-CREE COB,1MTR. TRACK, COLOUR-GRAY POWDER COATED WITH SILVER REFLECTOR	120	
	C5	JS-LTM-Cruise 15w Deep Recessed Cob Downlight	52	JS-LTM-CRUISE 15W DEEP RECESSED COB DOWNLIGHT,BRANDED LED: BRIDGELUX LED,MEDIUM (36-45"), NATURAL WHITE (4K)	780	
	C7	HANGING LIGHT	13	WATTAGE 36 WATT 3NOS=108 WATT	468	
	C8	DECORATIVE LIGHT	1	120 WATTAGE	120	

SITE:
FF-19_HYDERABAD
AIRPORT_International-West




DRAWING TITLE :
LIGHTING MARK-OUT LAYOUT
-CEILING-REV-1

MADE BY : AASTHA

DATE : 20TH FEB 2024 RO : 07

SUBWAY
EVERSUB India Pvt Ltd

OFFICE :-
SUBWAY SYSTEMS INDIA PRIVATE
LIMITED,
Aurika Space Solutions, 3rd Floor, Tower-B,
Unitach Cyber Park, Gurugram, Haryana,
India-122002.

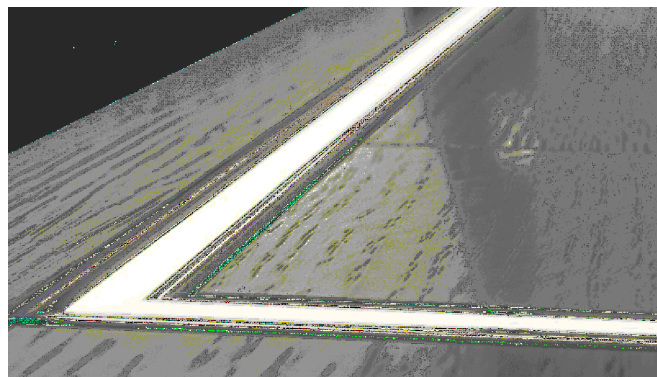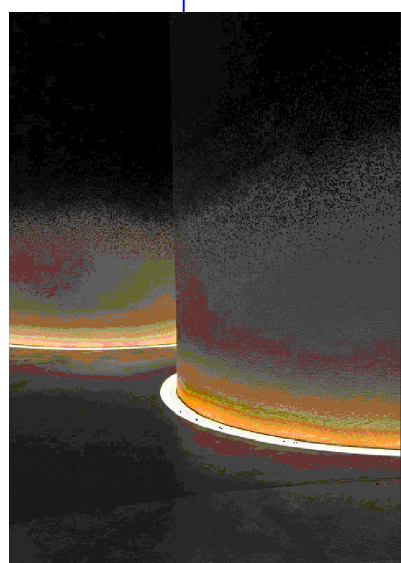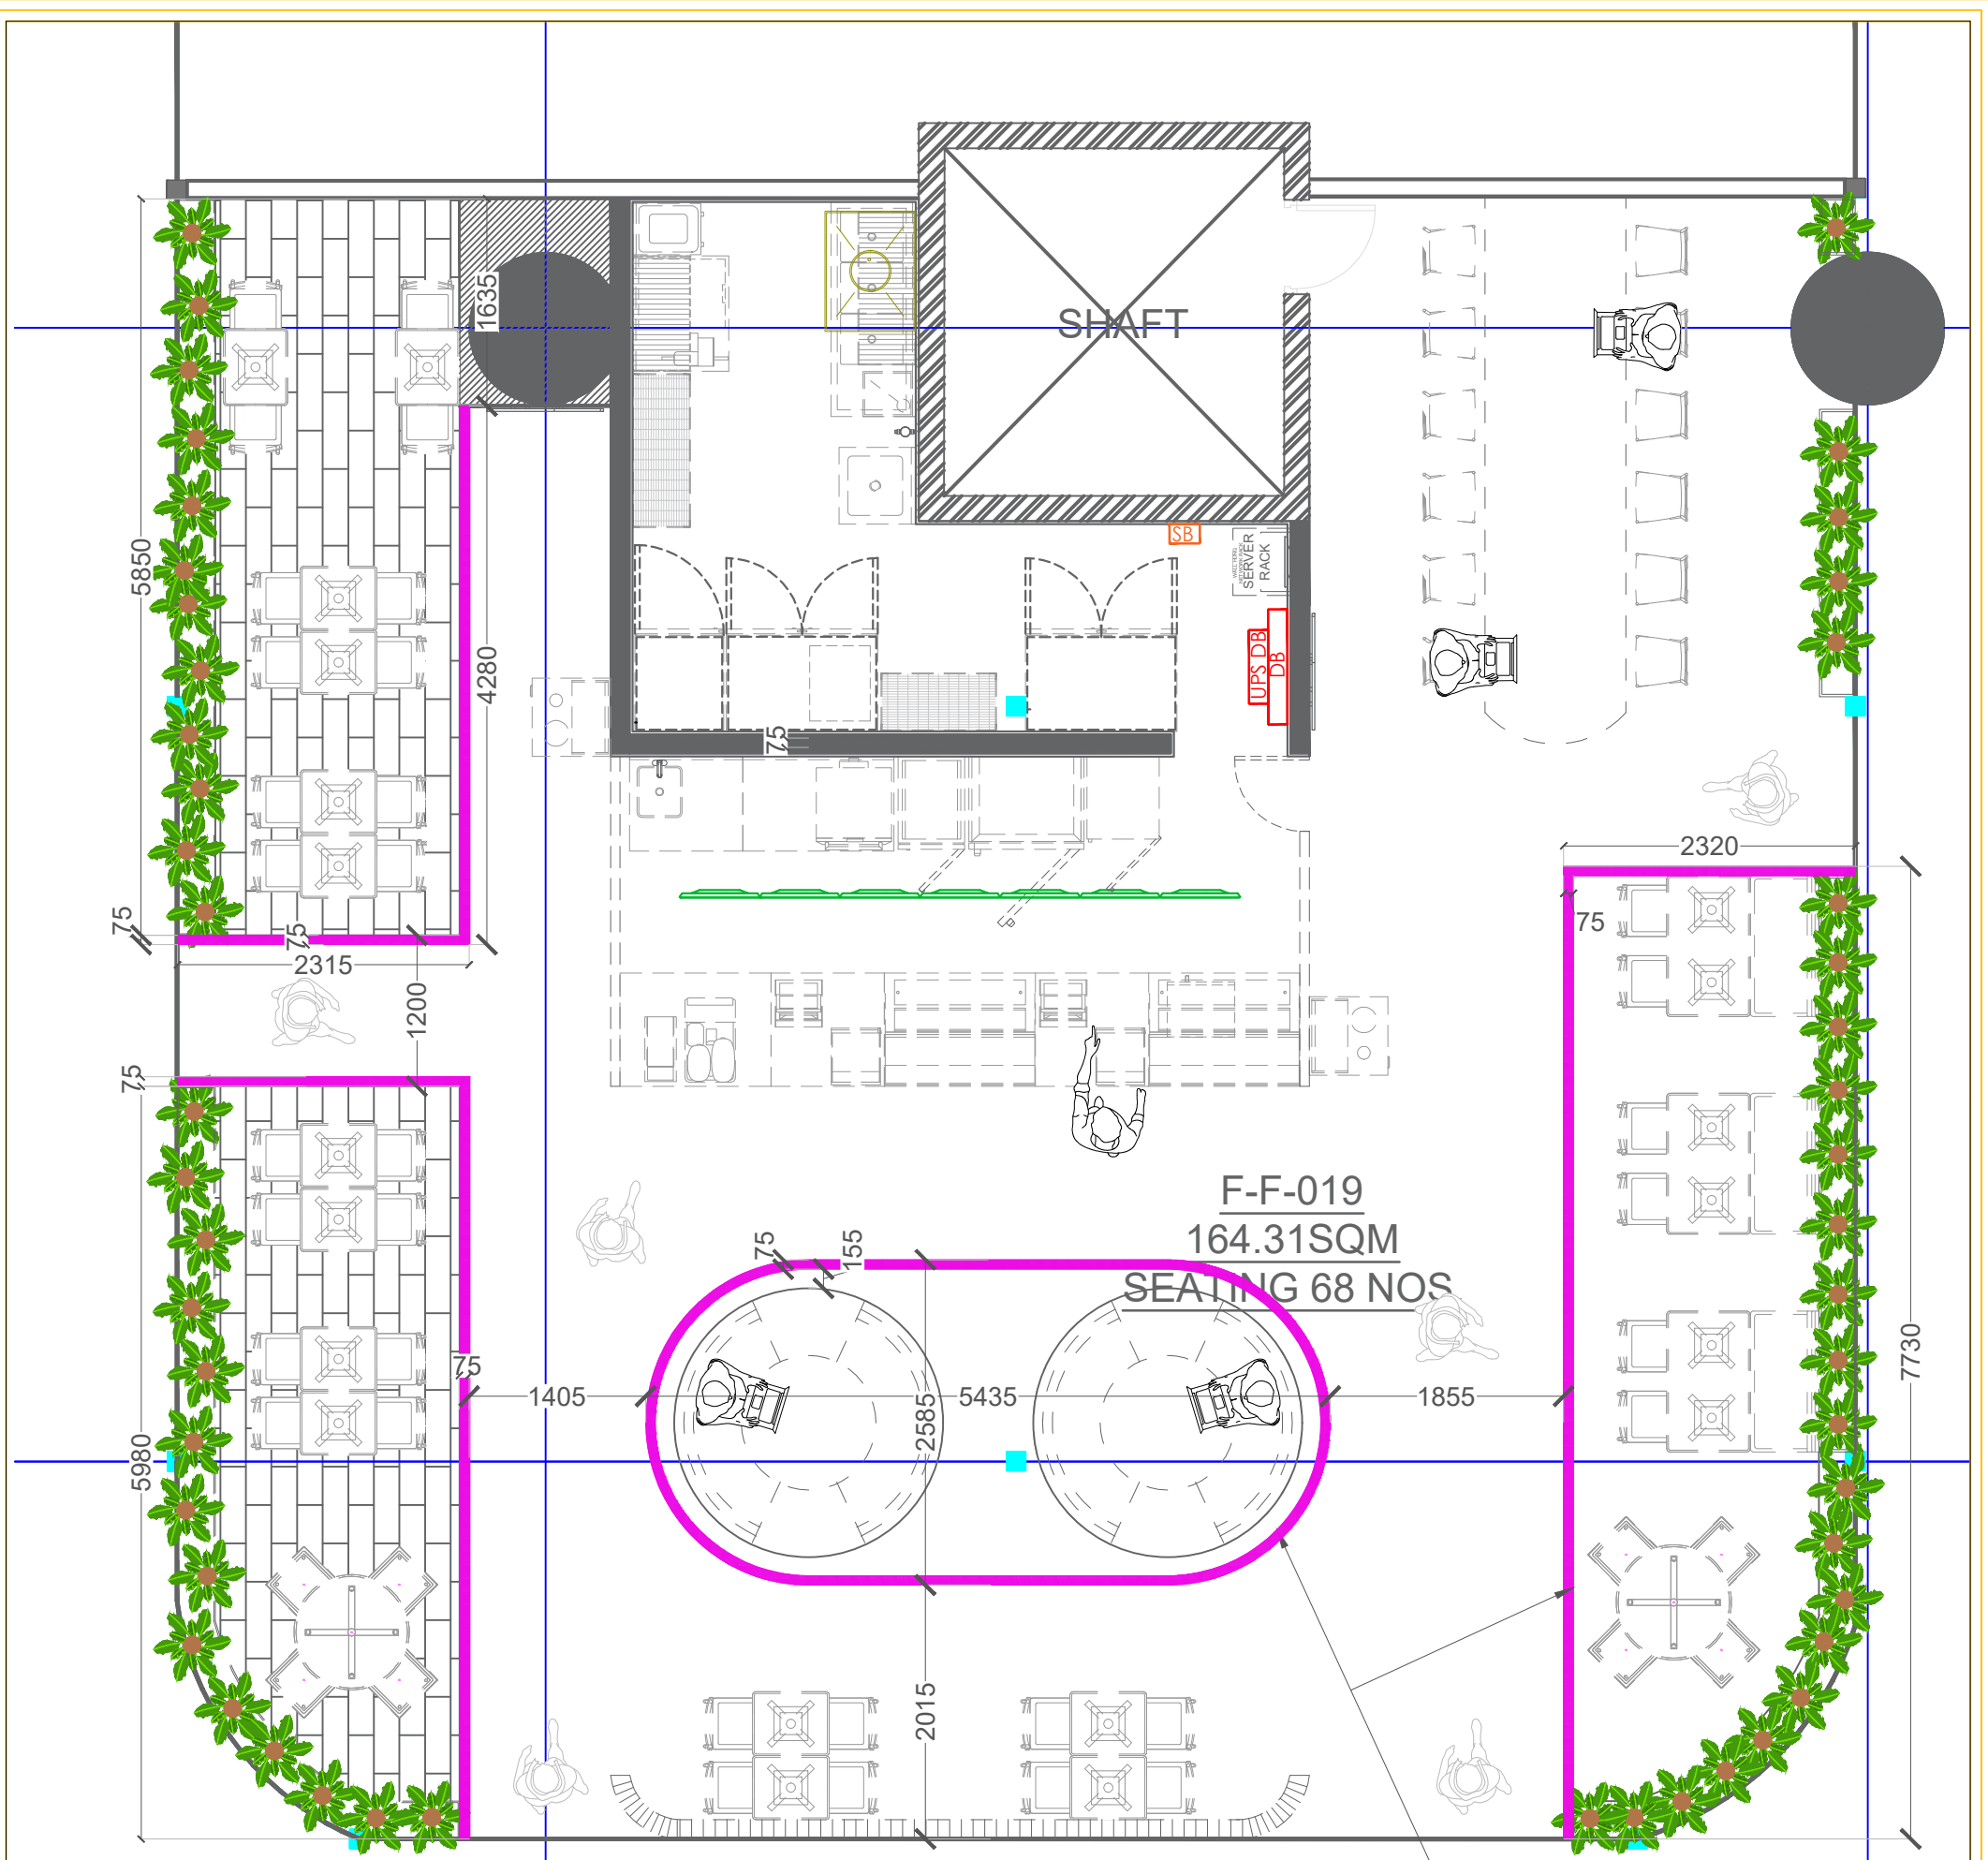

**WATERPROOF & SCRATCH PROOF
 FLOOR LED PROFILE LIGHT**

SITE:
 FF-19_HYDERABAD
 AIRPORT_International-West


DRAWING TITLE :
 LIGHTING MARK-OUT LAYOUT
 -FLOOR-REV-1

MADE BY AASTHA

DATE 22 FEB 2024 **RD** 07

SUBWAY
 EVERSUB India Pvt Ltd

OFFICE :-
 SUBWAY SYSTEMS INDIA PRIVATE
 LIMITED,
 Awfis Space Solutions, 3rd Floor, Tower-9,
 Unitech Cyber Park, Gurgaon, Haryana,
 India-122002.

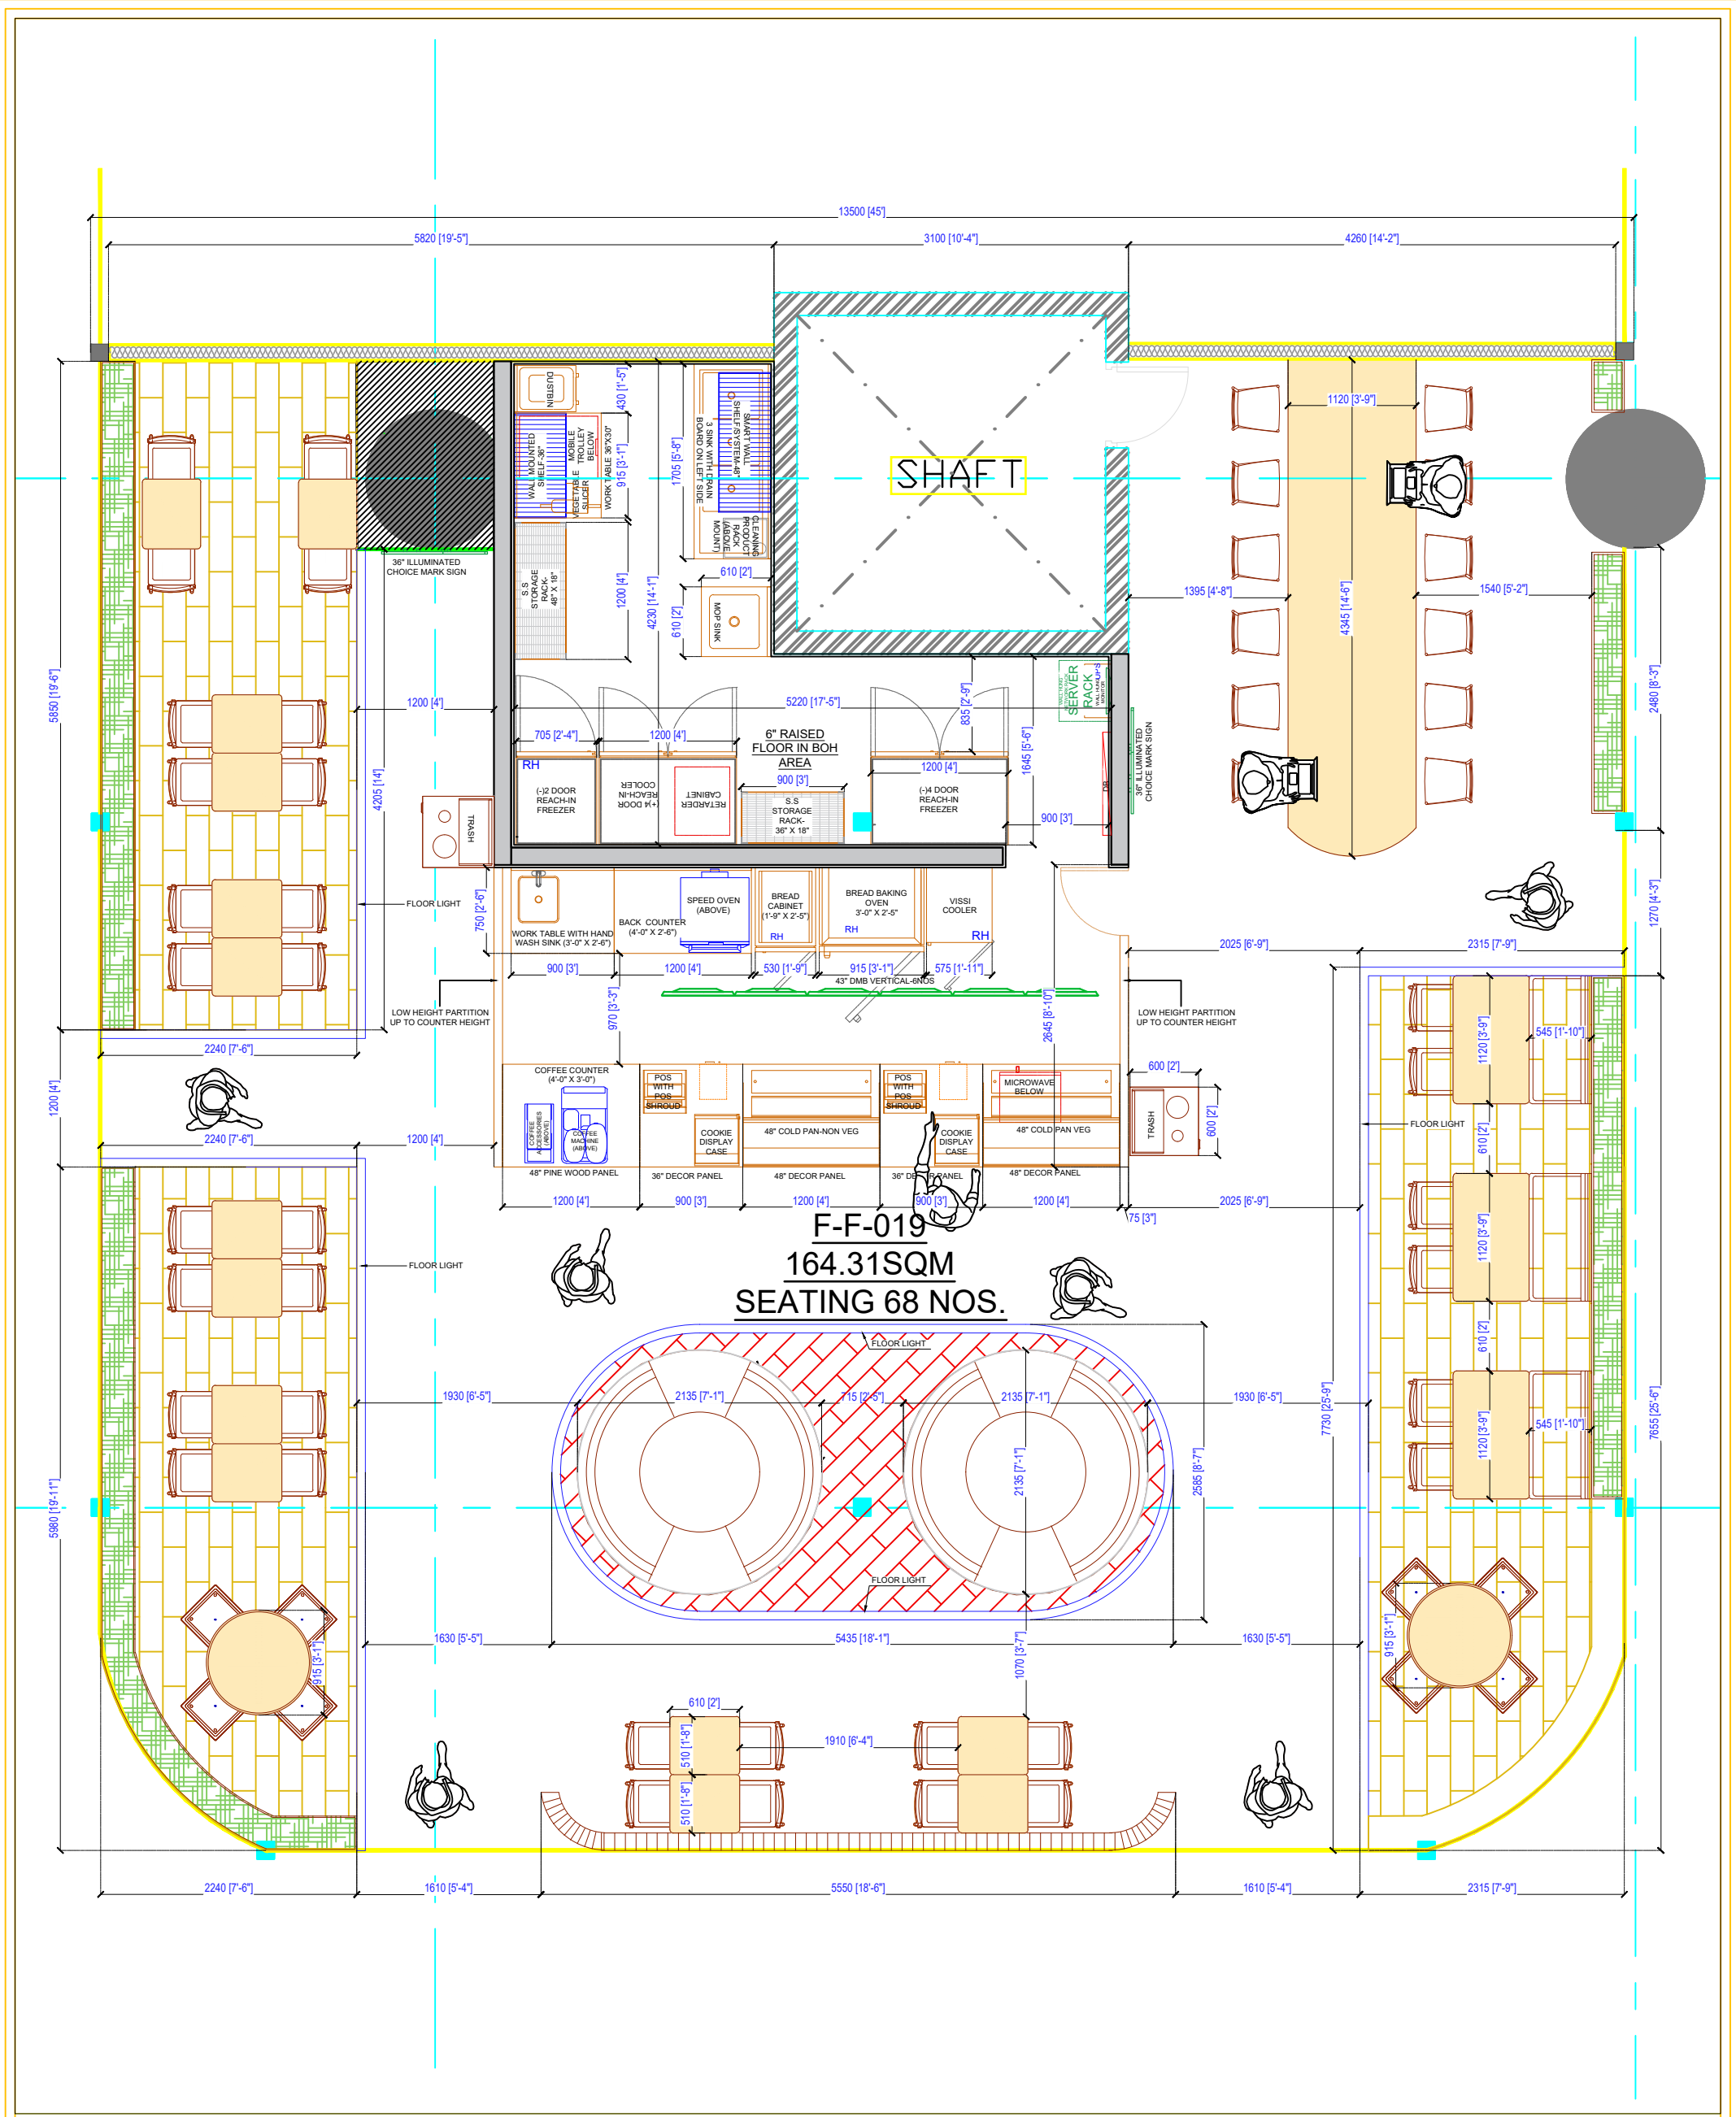

F-F-019
164.31 SQM
SEATING 68 NOS.

- * STORE FORMAT=AIRPORT KIOSK
- * CARPET AREA=164.31 SQM.
- * CUSTOMER AREA=130.88 SQM.
- * SERVICE AREA=13.43 SQM.
- * BOH AREA=20.00 SQM.

* CEILING HT. (BOTTOM OF CEILING)=11'-2"

* TOTAL SEATING=68 NOS.

* DMB= 6 NOS. 43" SCREEN (VERTICAL) @6'-6" BOTTOM FROM CUSTOMER AREA F.FL

SITE:
FF-19_HYDERABAD AIRPORT International-West


DRAWING TITLE:
EQUIPMENT & FURNITURE LAYOUT, OPTION-6

MADE BY: AASTHA

DATE: 22th FEB 2024 **RD:** 01

SUBWAY
EVERSUB India Pvt Ltd

OFFICE :-
 SUBWAY SYSTEMS INDIA PRIVATE LIMITED,
 Awfis Space Solutions, 3rd Floor, Tower-9,
 Unitech Cyber Park, Gurgaon, Haryana,
 India-122002.

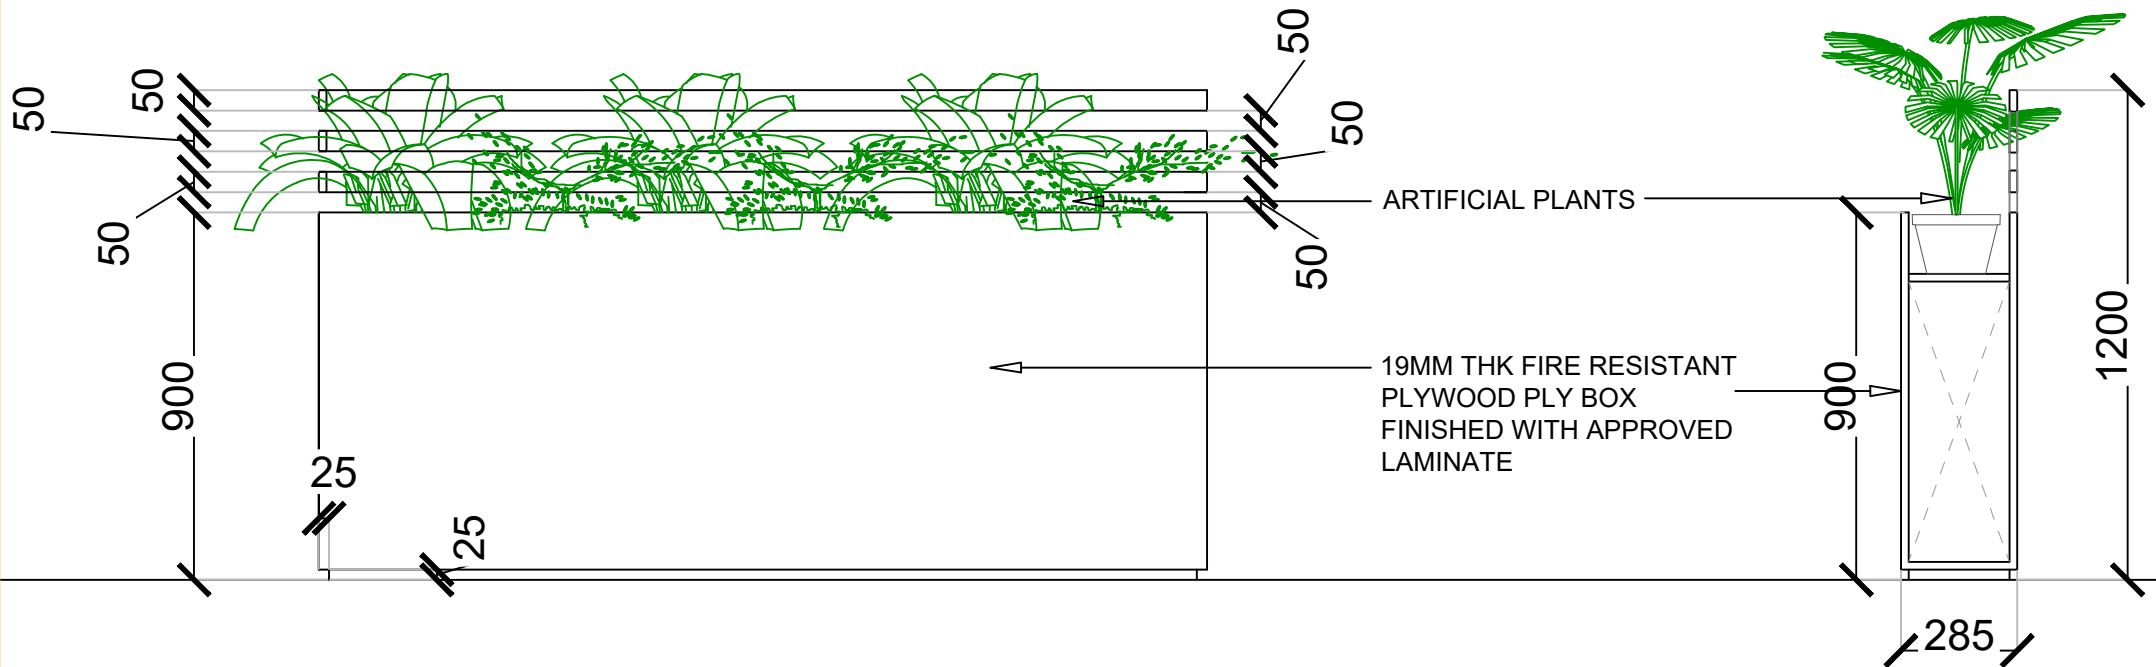


ELEVATION

SIDE ELEVATION

PLY SUPPORT FOR FRAME DESIGN


19MM THK FIRE RESISTANT PLYWOOD PLY BOX FINISHED WITH APPROVED LAMINATE

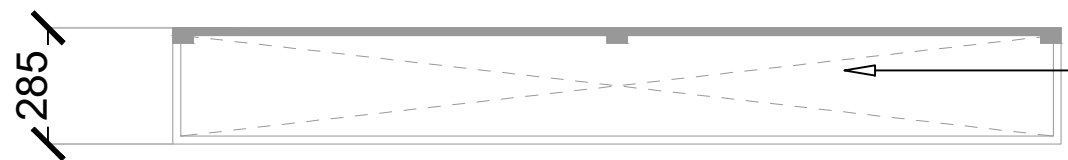

PLAN

PARTITION DETAIL -A

SITE: FF-19_HYDERABAD AIRPORT_International-West			
DRAWING TITLE : DETAIL-02			
MADE BY	AASTHA		
DATE	10th JAN 2024	RO	00
EVERSUB India Pvt Ltd OFFICE :- SUBWAY SYSTEMS INDIA PRIVATE LIMITED, Aarfa Space Solutions, 3rd Floor, Tower-B, Unitech Cyber Park, Gurugram, Haryana, India-122002.			

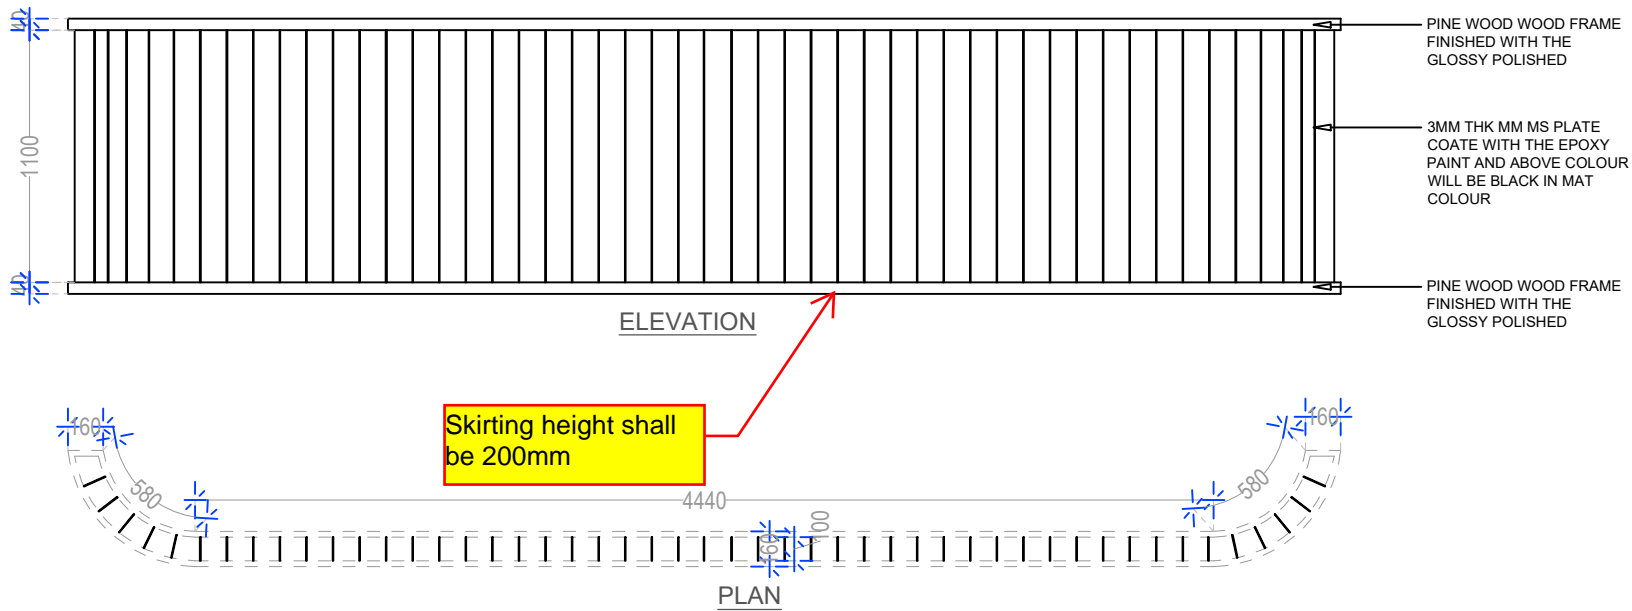

REFERENCE IMAGE

PARTITION DETAIL-B

SITE:
FF-19_HYDERABAD
AIRPORT_International-West

DRAWING TITLE :
DETAIL-03


MADE BY | AASTHA

DATE | 10th JAN 2024 | RO | 00

SUBWAY
 EVERSUB India Pvt Ltd
 OFFICE :-
 SUBWAY SYSTEMS INDIA PRIVATE
 LIMITED,
 Aarfa Space Solutions, 3rd Floor, Tower-B,
 Unitech Cyber Park, Gurgaon, Haryana,
 India-122002.



FRONT ELEVATION

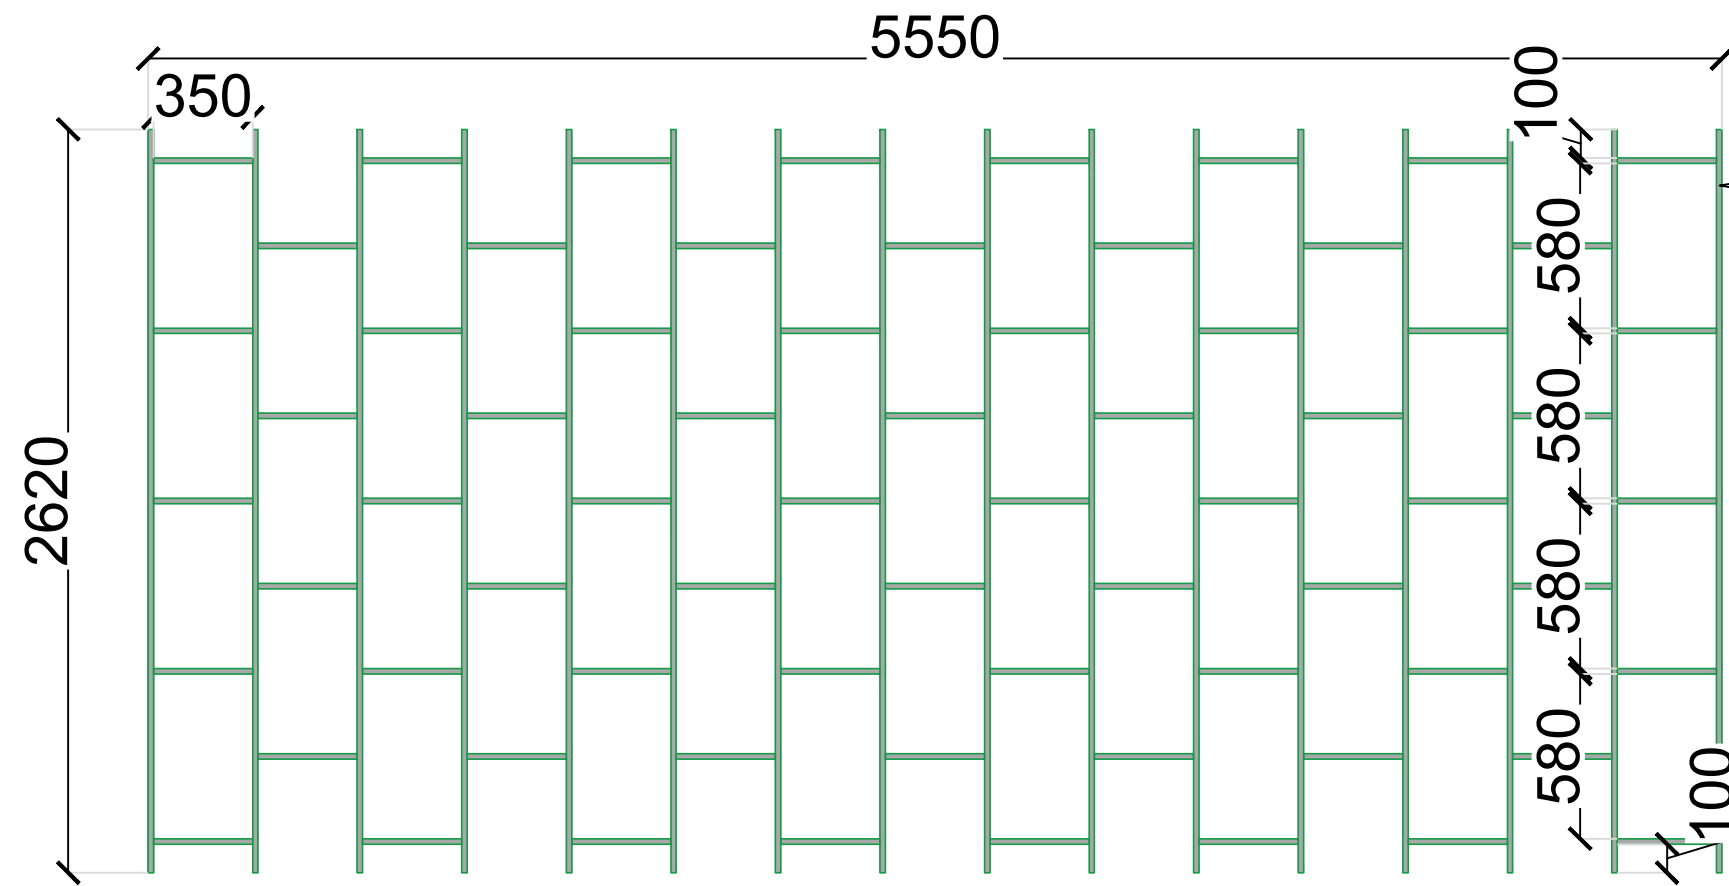


NOTE-THE CEILING WILL BE FIXED ABOVE DMB

PLAN

SERVICE AREA ABOVE CEILING

19 MM THK RUBBER WOOD FRAME FINISHED WITH THE TOUCHWOOD POLISHED (Nails and other necessary material will be used to create the frame, which will then be covered with polished).

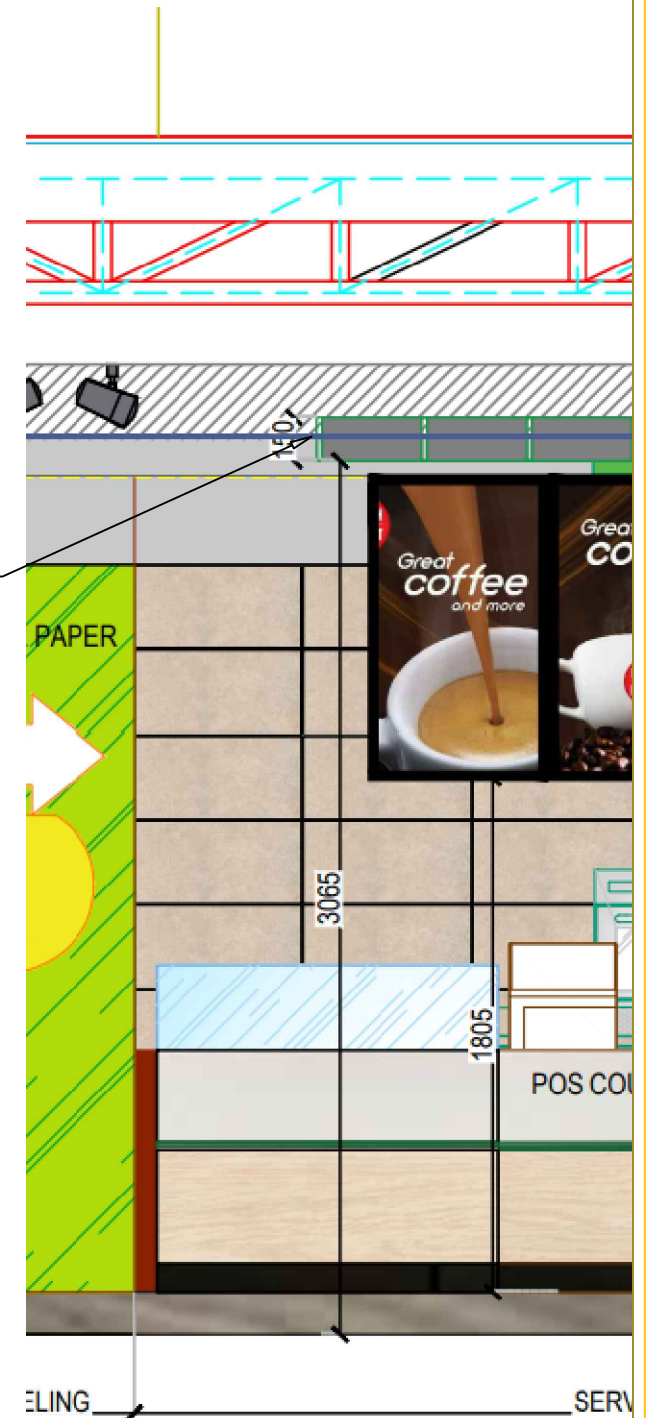


SITE:	
FF-19_HYDERABAD AIRPORT_International-West	
DRAWING TITLE :	
DETAIL-04	
MADE BY	AASTHA
DATE	10th JAN 2024
RO	00
EVERSUB India Pvt Ltd	
<small>OFFICE :- SUBWAY SYSTEMS INDIA PRIVATE LIMITED, Awfis Space Solutions, 3rd Floor, Tower-B, Unitech Cyber Park, Grurgram, Haryana, India-122002.</small>	




Note- Before applying on site, kindly approve the MDF 3D board sample from SUBWAY team.

F A C A D E _ E L E V A T I O N

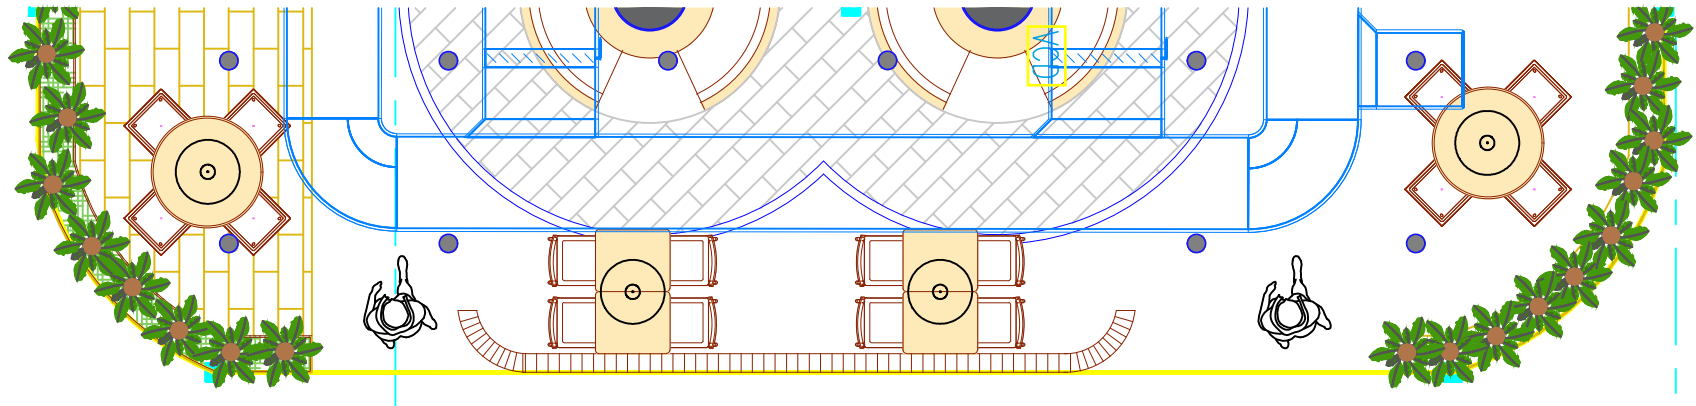

P L A N


SITE:			
FF-19_HYDERABAD			
AIRPORT_International-West			
DRAWING TITLE :			
FACADE ELEVATION			
MADE BY	AASTHA		
DATE	10th JAN 2024	RO	00
EVERSUB India Pvt Ltd OFFICE :- SUBWAY SYSTEMS INDIA PRIVATE LIMITED, Aarfa Space Solutions, 3rd Floor, Tower-B, Unitech Cyber Park, Gurugram, Haryana, India-122002.			

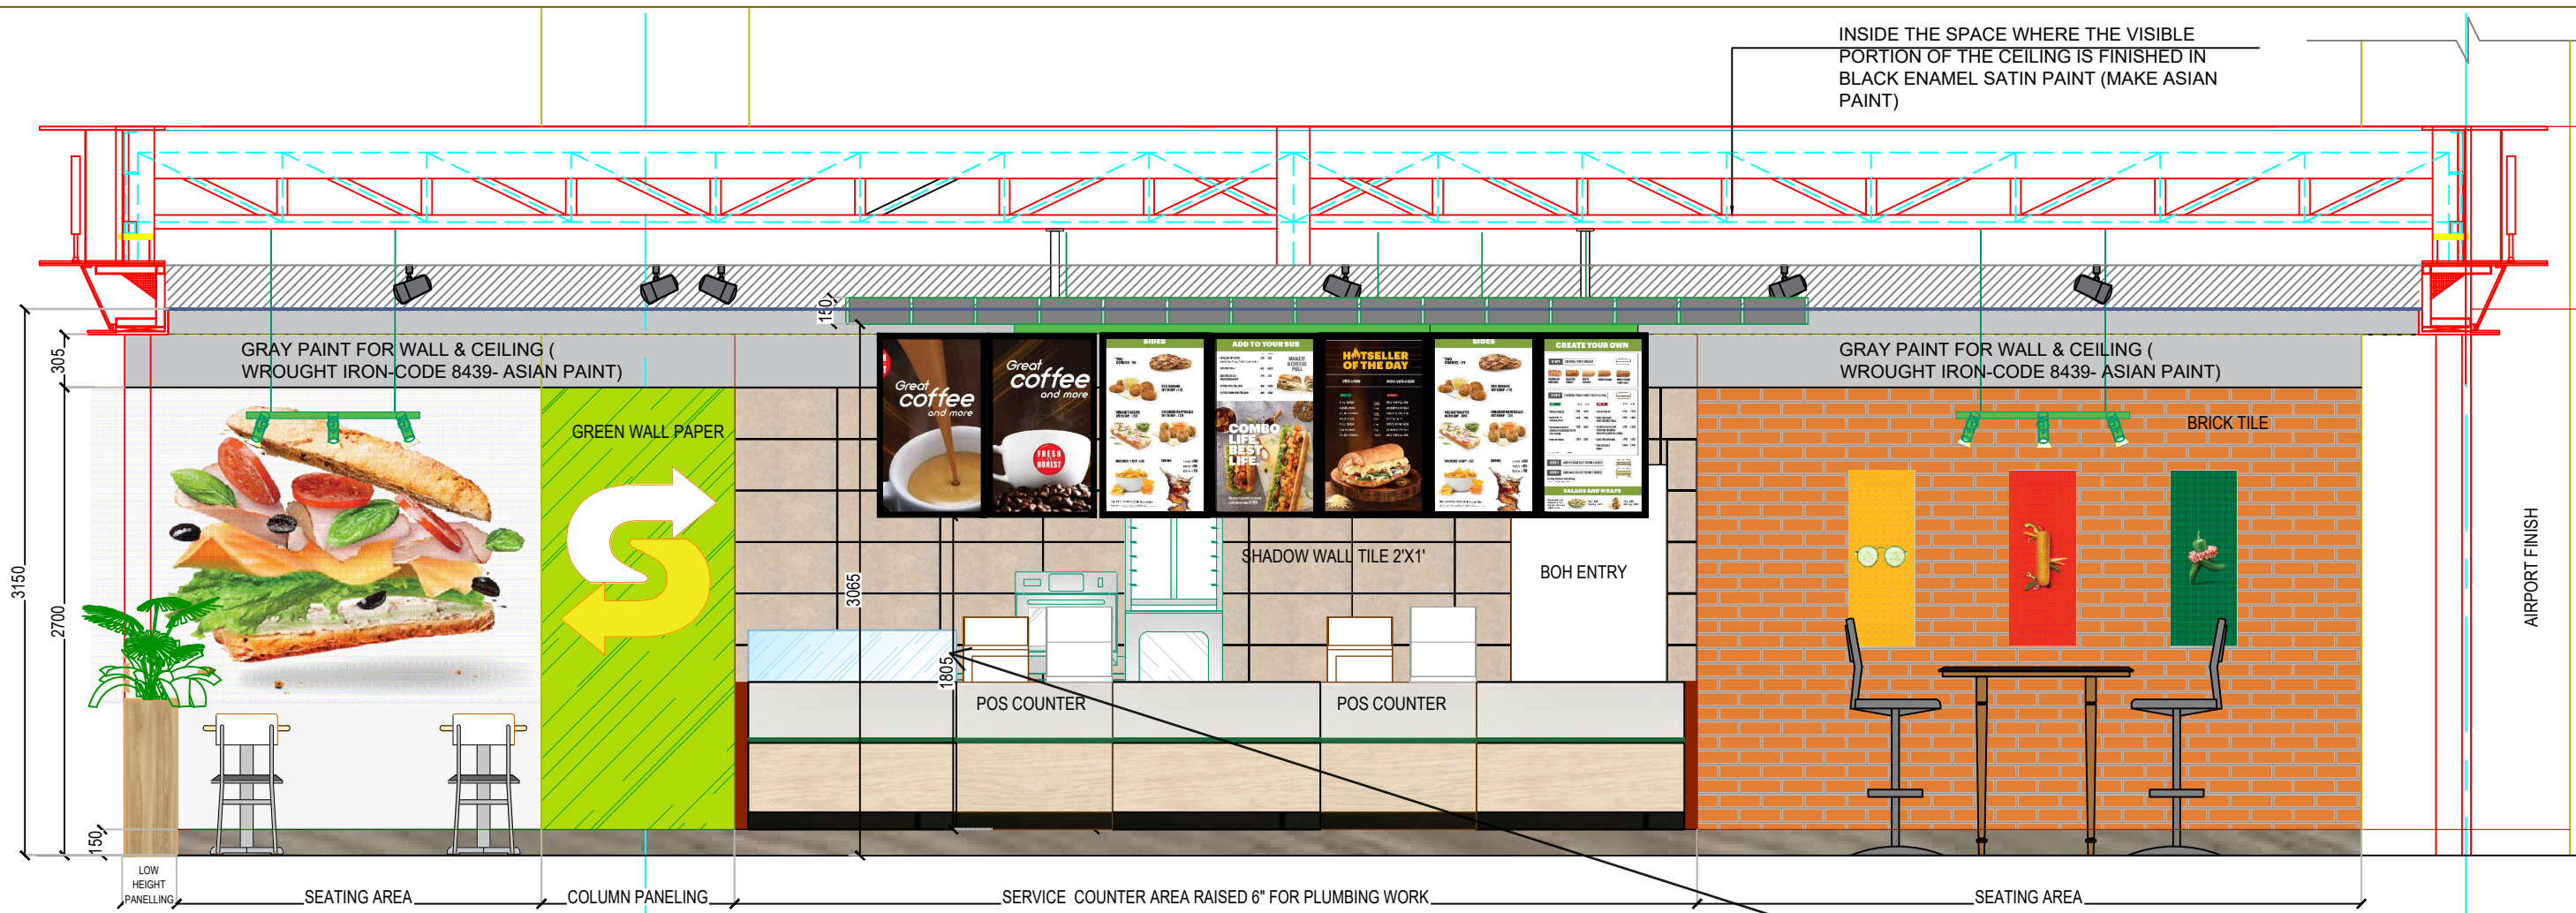

- NOTE-**
1. ALL FINISHES FINISHED AT 9 FEET HEIGHT
 2. SKIRTING HEIGHT 6" FROM FINISHED FLOOR LEVEL

Height of the TV bottom to be 1950mm (min) from FFL. To be adjusted at site.

STORE ELEVATION - 1

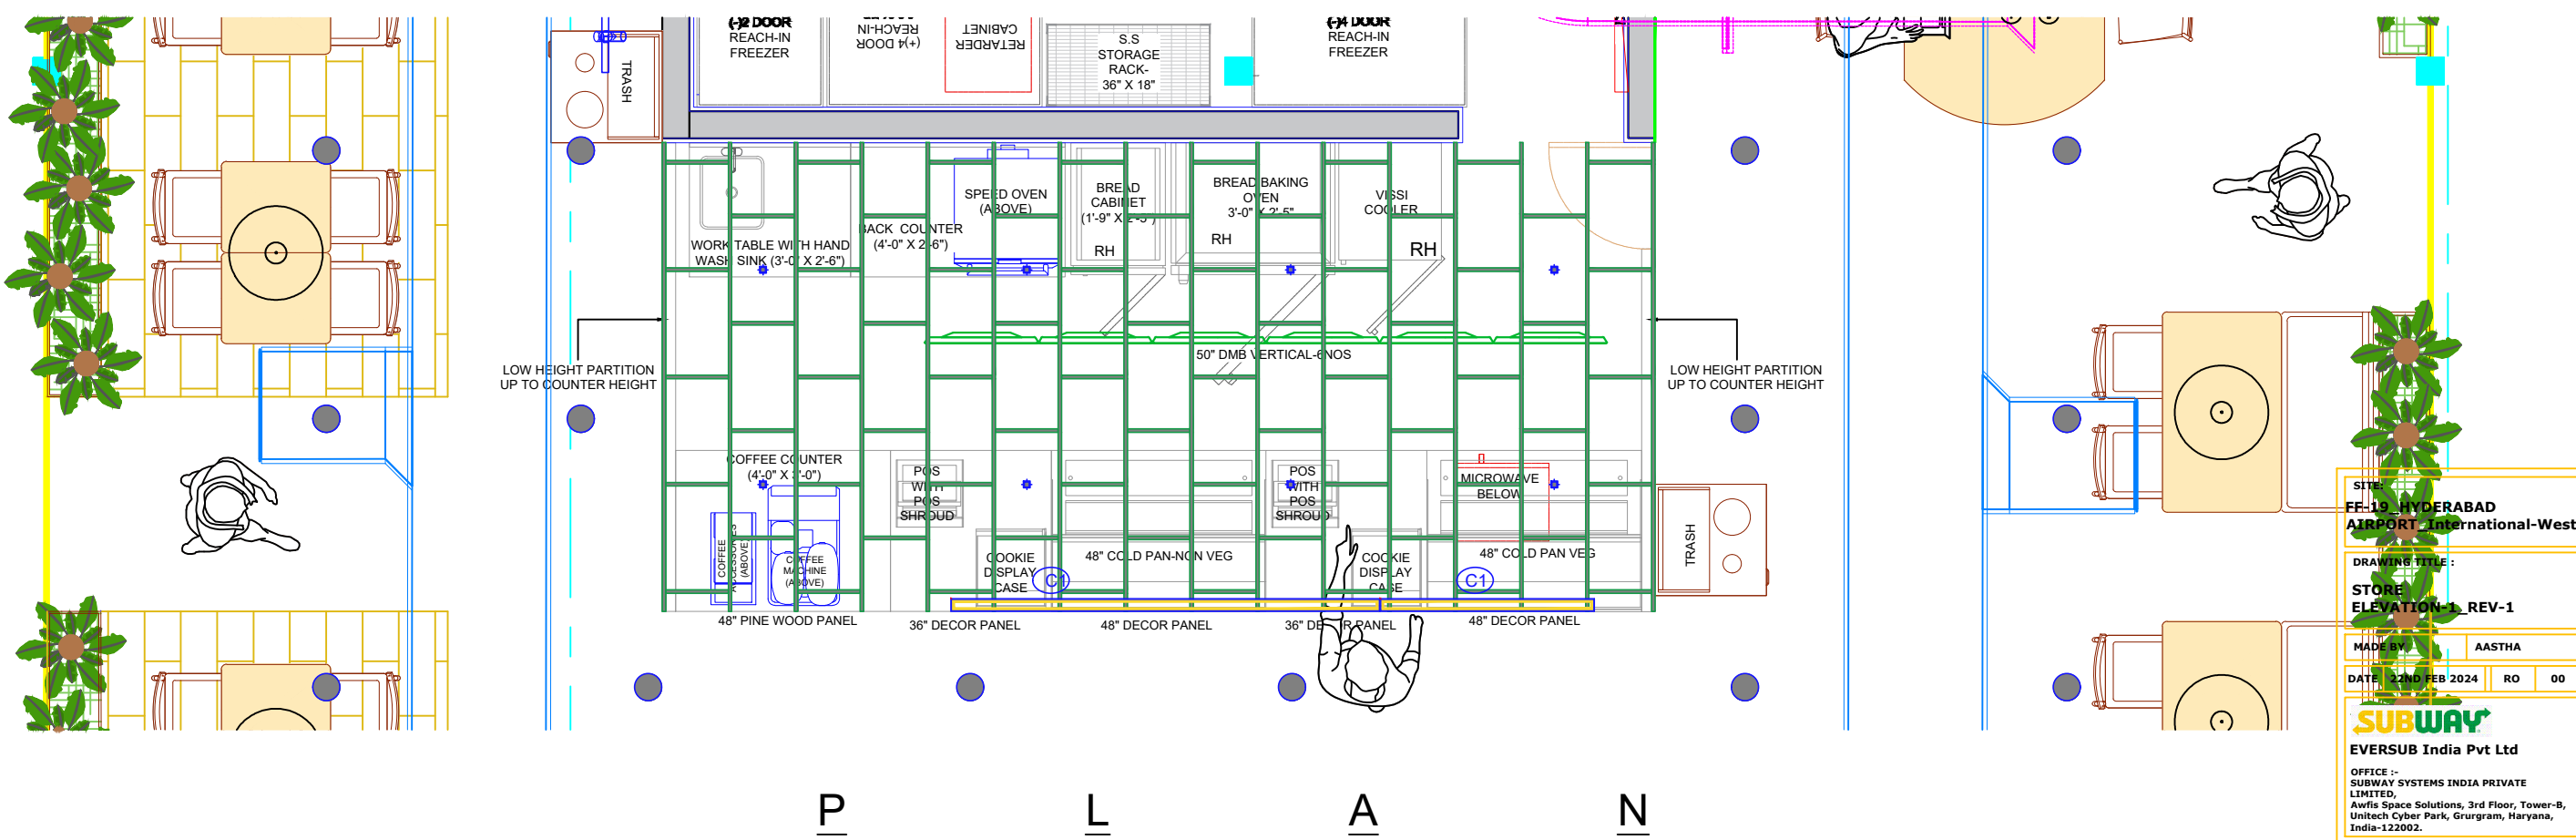

SITE: FF-19 HYDERABAD AIRPORT International-West

DRAWING TITLE: STORE ELEVATION-1_REV-1


MADE BY: AASTHA

DATE: 22ND FEB 2024 RO: 00


SUBWAY

EVERSUB India Pvt Ltd

OFFICE :- SUBWAY SYSTEMS INDIA PRIVATE LIMITED, Awfis Space Solutions, 3rd Floor, Tower-B, Unitech Cyber Park, Grurgram, Haryana, India-122002.

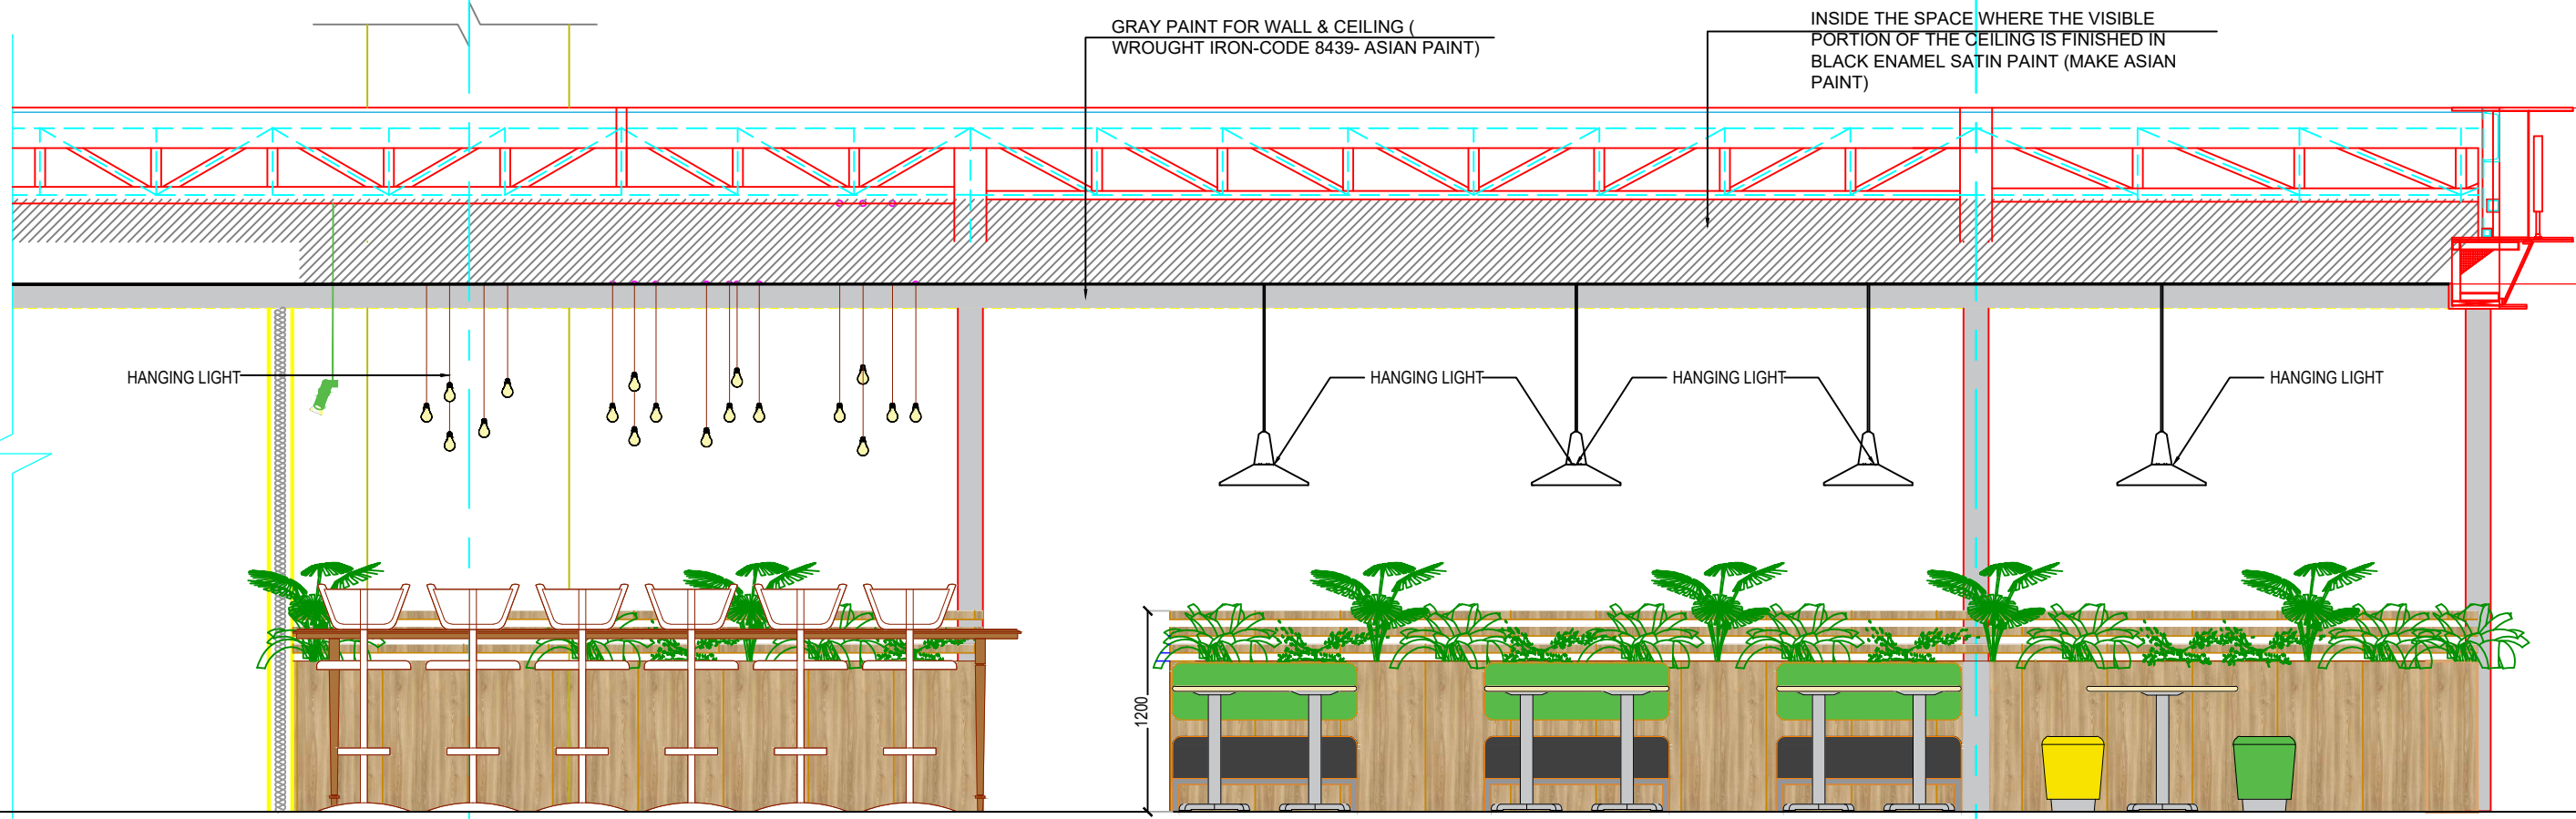

S T O R E _ E L E V A T I O N _ - 2

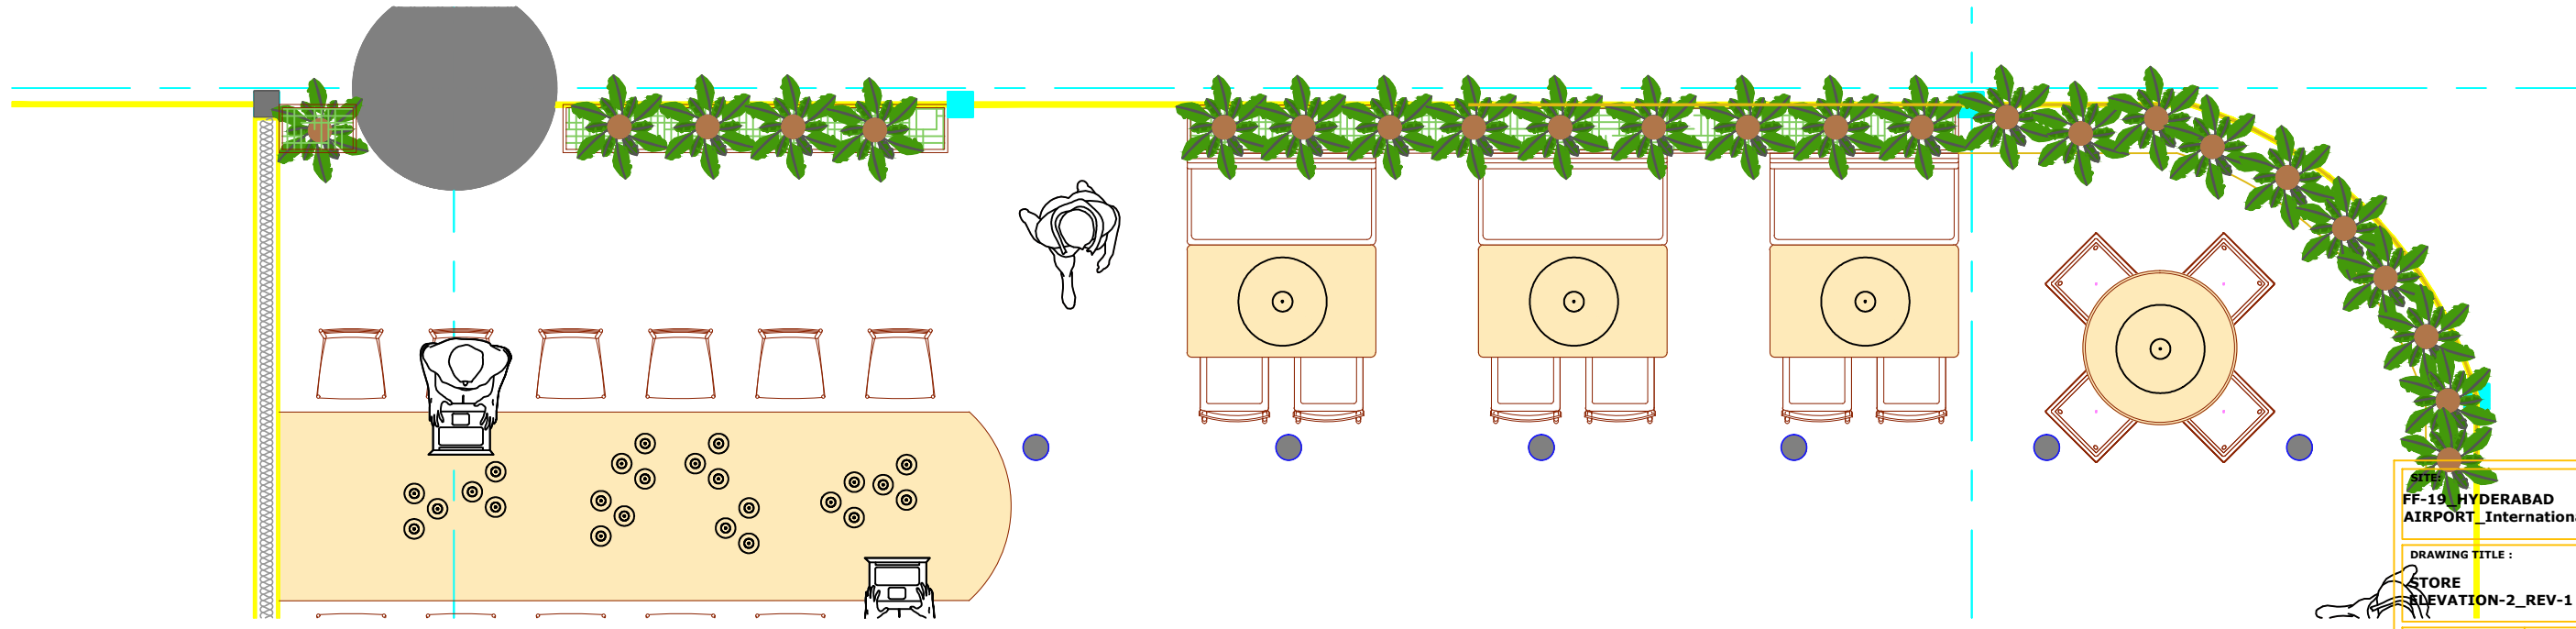

SITE :
FF-19 HYDERABAD
AIRPORT International-West

DRAWING TITLE :
STORE
ELEVATION-2_REV-1

MADE BY : **AASTHA**

DATE : **22ND FEB 2024** RO : OO :

SUBWAY
EVERSUB India Pvt Ltd

OFFICE :-
 SUBWAY SYSTEMS INDIA PRIVATE
 LIMITED,
 Awfis Space Solutions, 3rd Floor, Tower-B,
 Unitech Cyber Park, Grurgram, Haryana,
 India-122002.




GRAY PAINT FOR WALL & CEILING (WROUGHT IRON-CODE 8439- ASIAN PAINT)

INSIDE THE SPACE WHERE THE VISIBLE PORTION OF THE CEILING IS FINISHED IN BLACK ENAMEL SATIN PAINT (MAKE ASIAN PAINT)

COLUMN FINISHED IN PAINT (WROUGHT IRON CODE 8439 FROM ASIAN PAINTS)

LOW HEIGHT PARTITION

STORE ELEVATION - 3

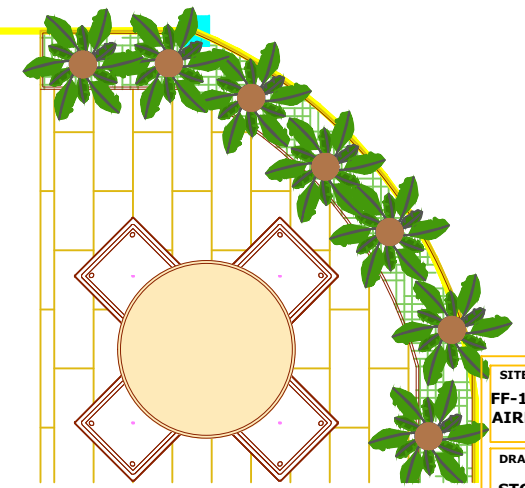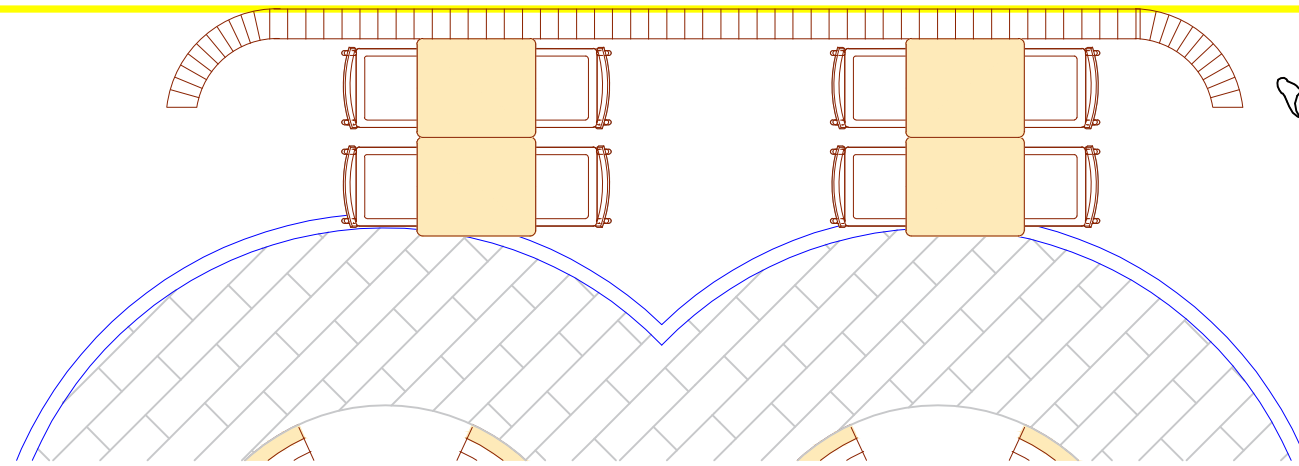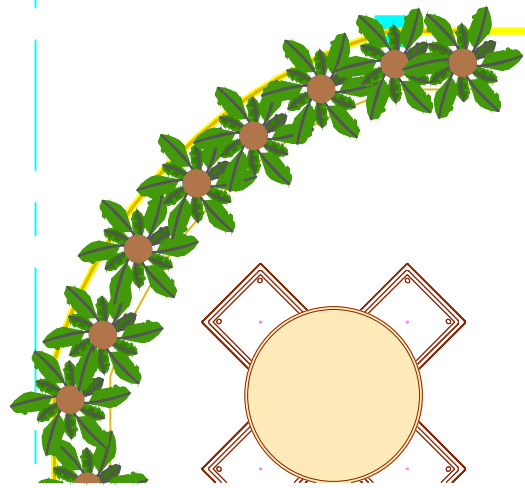

P L A N

SITE:
FF-19_HYDERABAD
AIRPORT_International-West


DRAWING TITLE :
STORE
ELEVATION-3_REV-1

MADE BY : AASTHA

DATE : 22ND FEB 2024 RO 00

SUBWAY
EVERSUB India Pvt Ltd

OFFICE :-
SUBWAY SYSTEMS INDIA PRIVATE
LIMITED,
Awfis Space Solutions, 3rd Floor, Tower-B,
Unittech Cyber Park, Grurgram, Haryana,
India-122002.

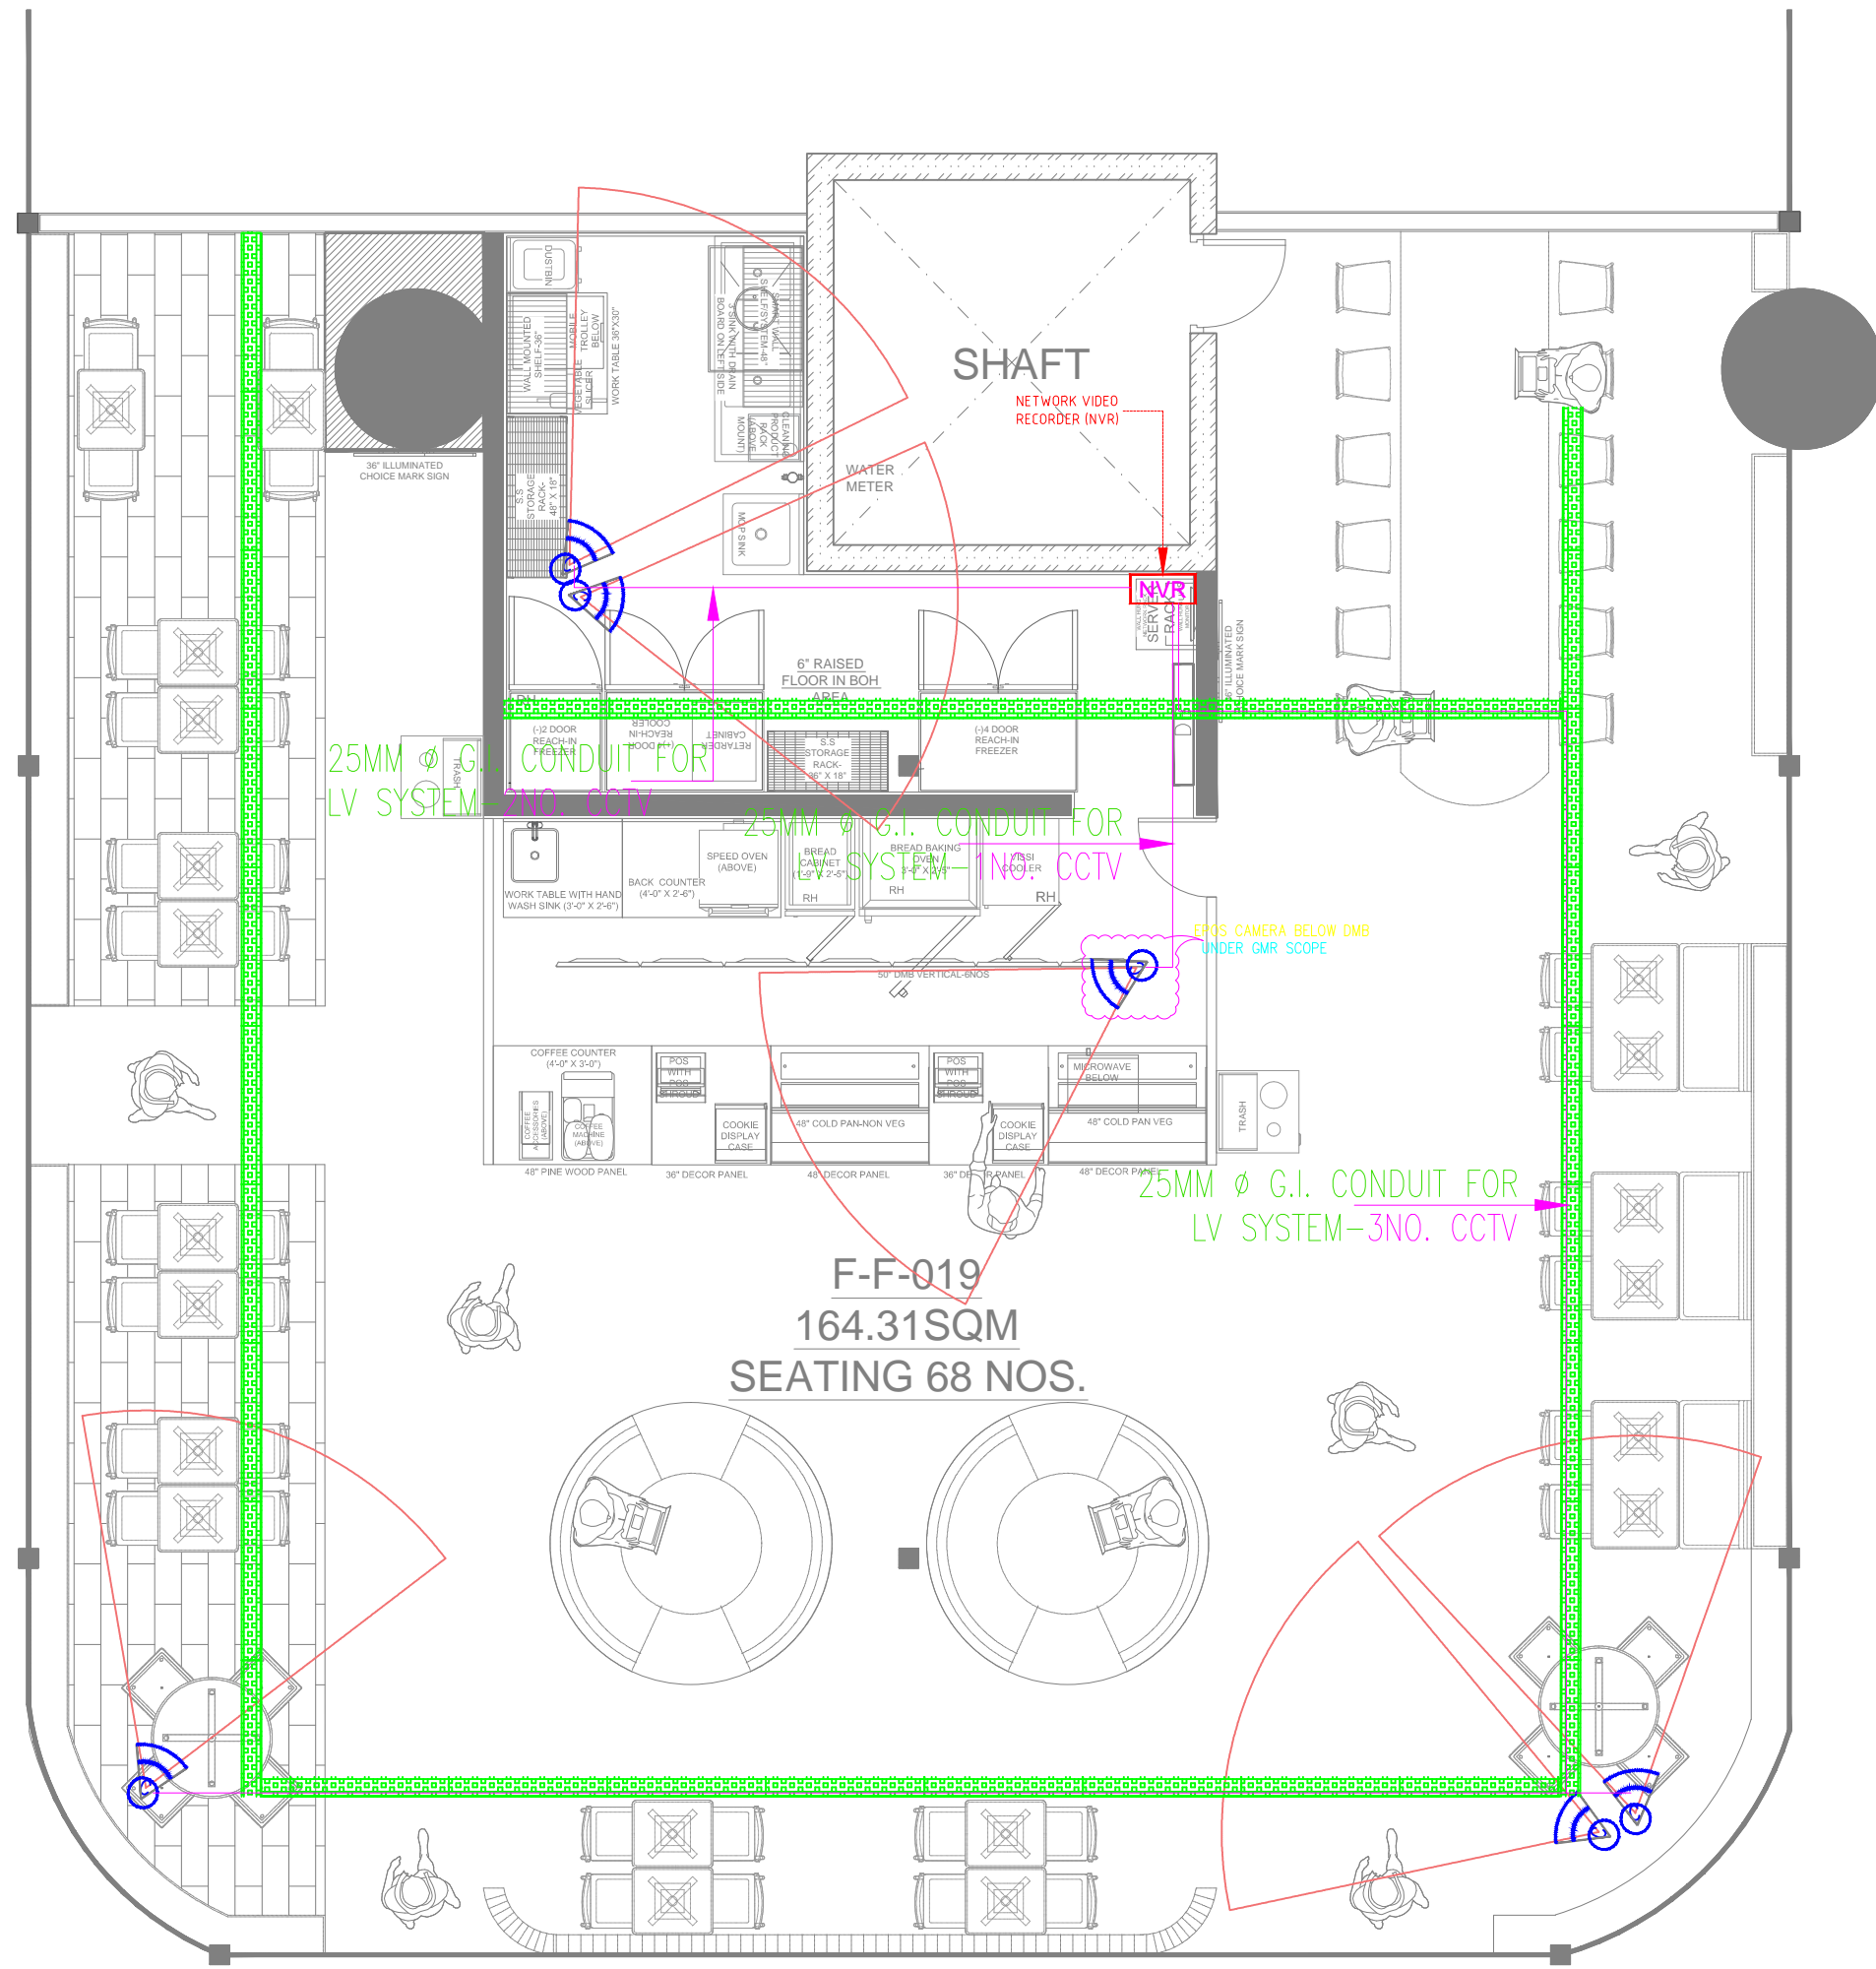


NOTE:-
Cat6 Cable of Belden Make shall be made available
above POS below ceiling for fixing GMR-EPOS camera

CCTV SYS LEGEND:-

SYMBOL	DESCRIPTION
	FIXED DOME CAMERA IR RANGE - CAMERA @8FT. AFFL
	NVR
	SERVER RACK
	CAT-6 CABLE

ADD ADDITIONAL CAT-6 POINT ABOVE DMB AREA & SERVER AREA @ 4FEET HEIGHT
UPS SUPPLY TO BE PROVIDED, BACK UP OF MINIMUM HALF & HOUR

MEPCONSULTANT:



US CONSULTANTS
C-47, SECOND FL.
SECTOR -2, NOIDA - 201301
TEL: +911204206093,4555284
+91 9999 200799
Email: info@usconsultants.in
website: www.usconsultants.in

SITE:
FF-19_HYDERABAD
AIRPORT_International-West

DRAWING TITLE :
CCTV LAYOUT



MADE BY :- ISHANK | CHECKED BY :- SATISH

DATE | 02nd APRIL 2024 | RO-01 | LV-01




EVERSUB India Pvt Ltd
OFFICE :-
SUBWAY SYSTEMS INDIA PRIVATE LIMITED,
Awfis Space Solutions, 3rd Floor, Tower-B,
Unitech Cyber Park, Grurgram, Haryana,
India-122002.


F-F-019
164.31SQM
SEATING 68 NOS.

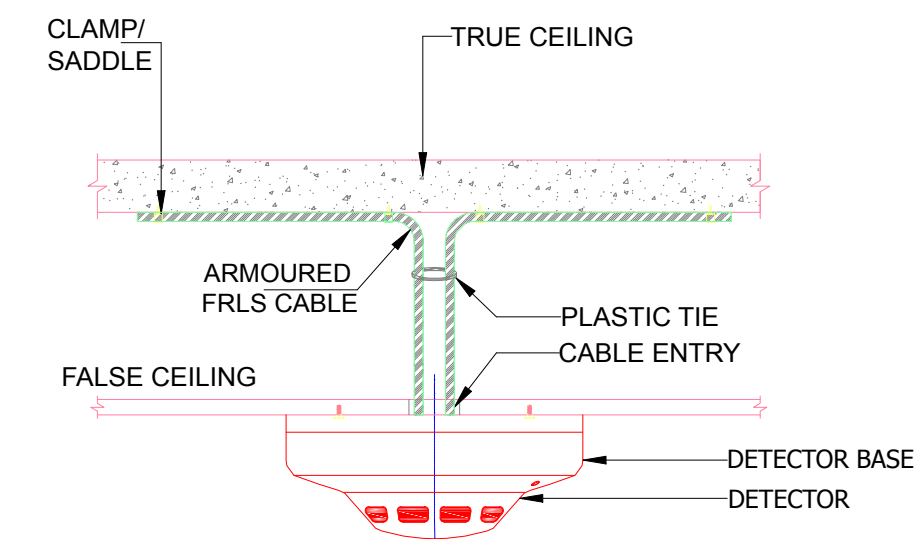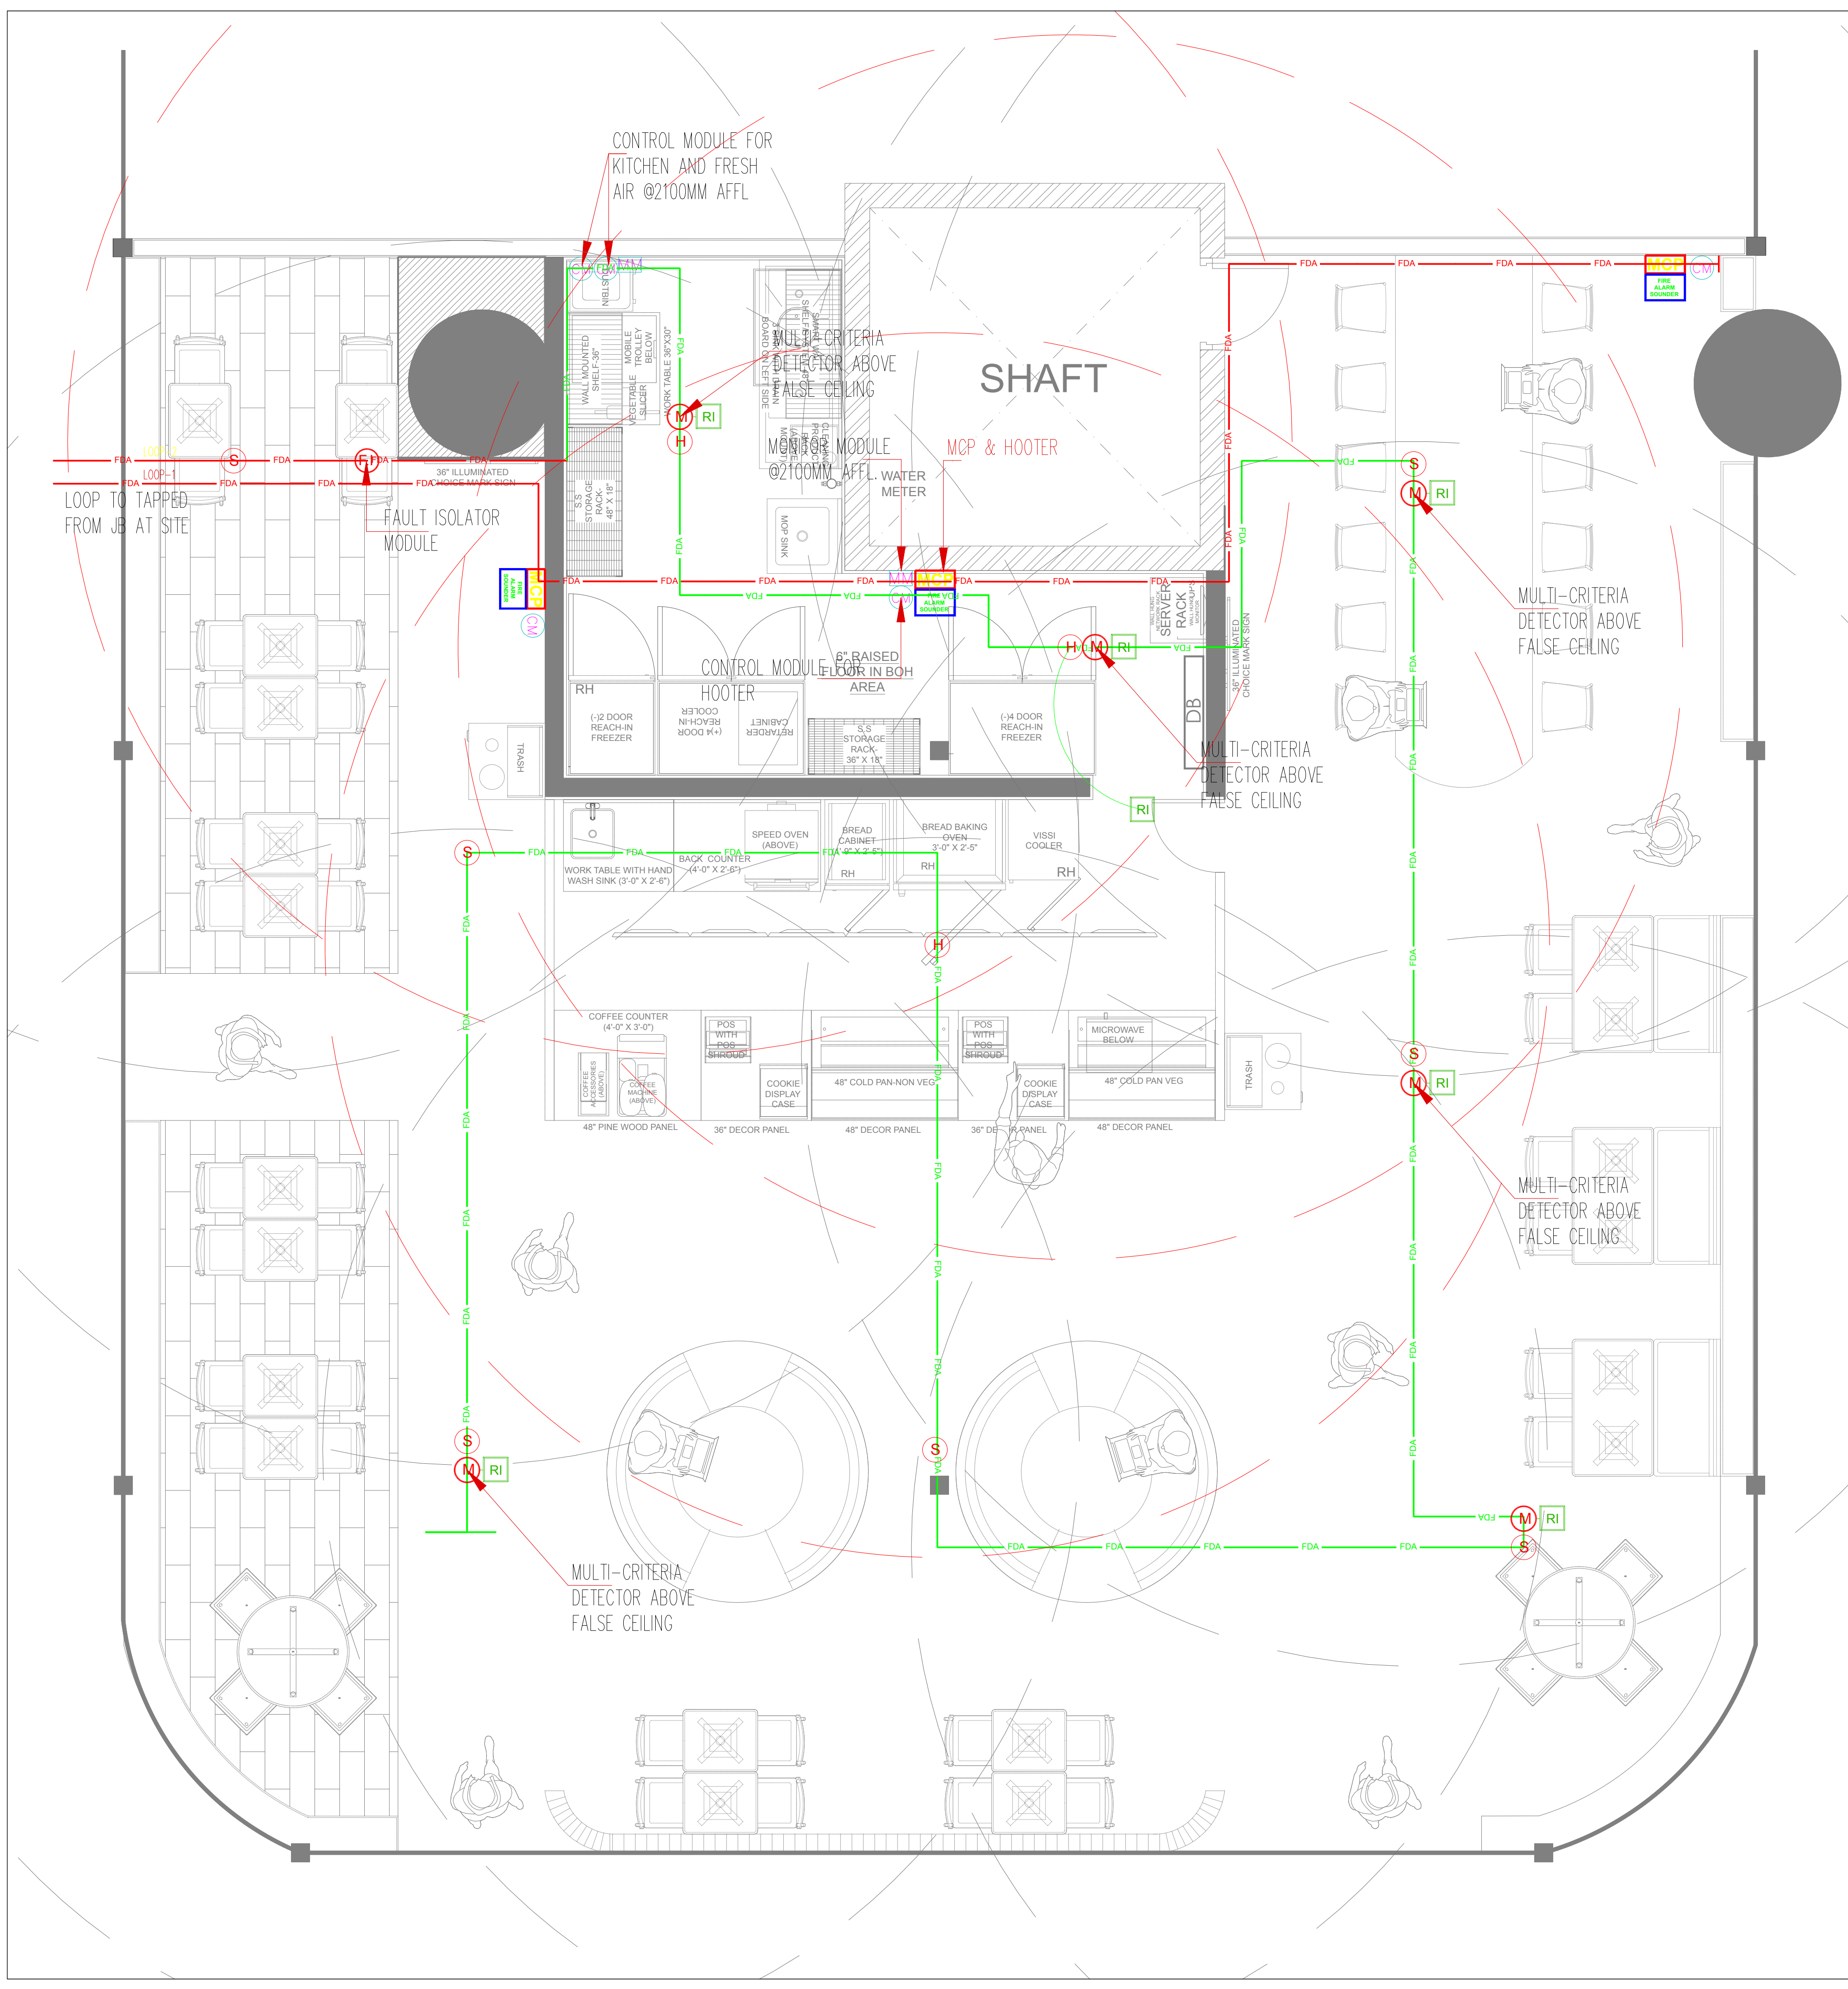

TYPICAL FIXING DETAIL OF DETECTOR AT BELOW FALSE CEILING AREA

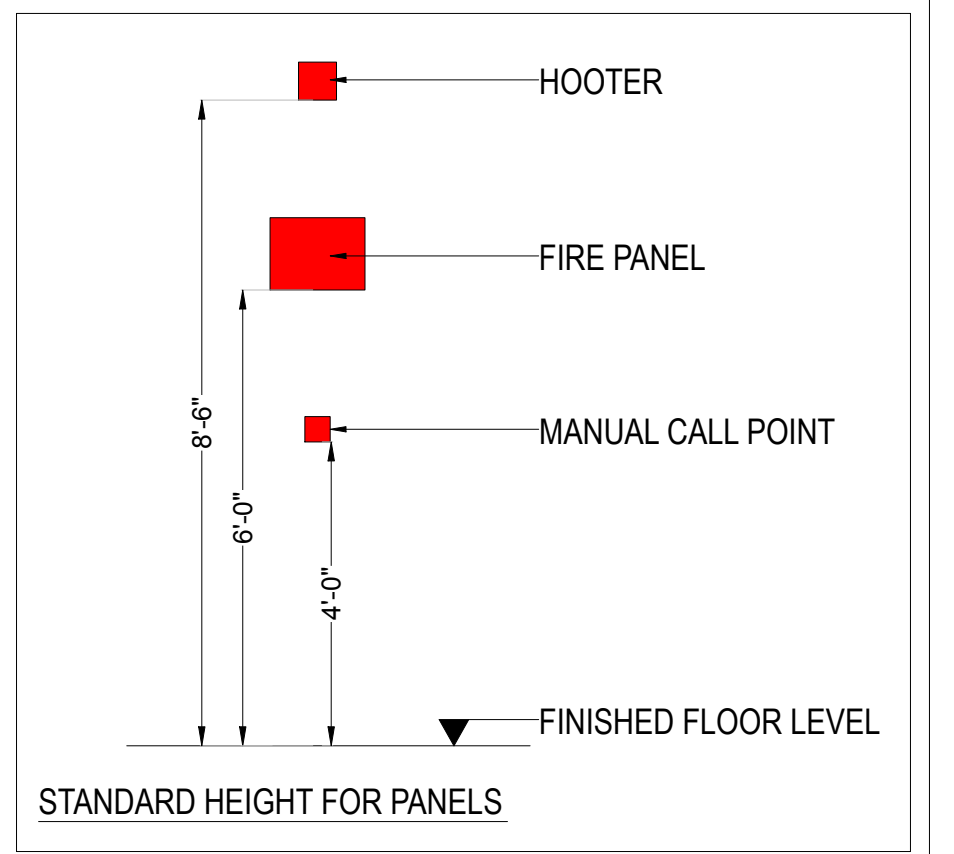

STANDARD HEIGHT FOR PANELS

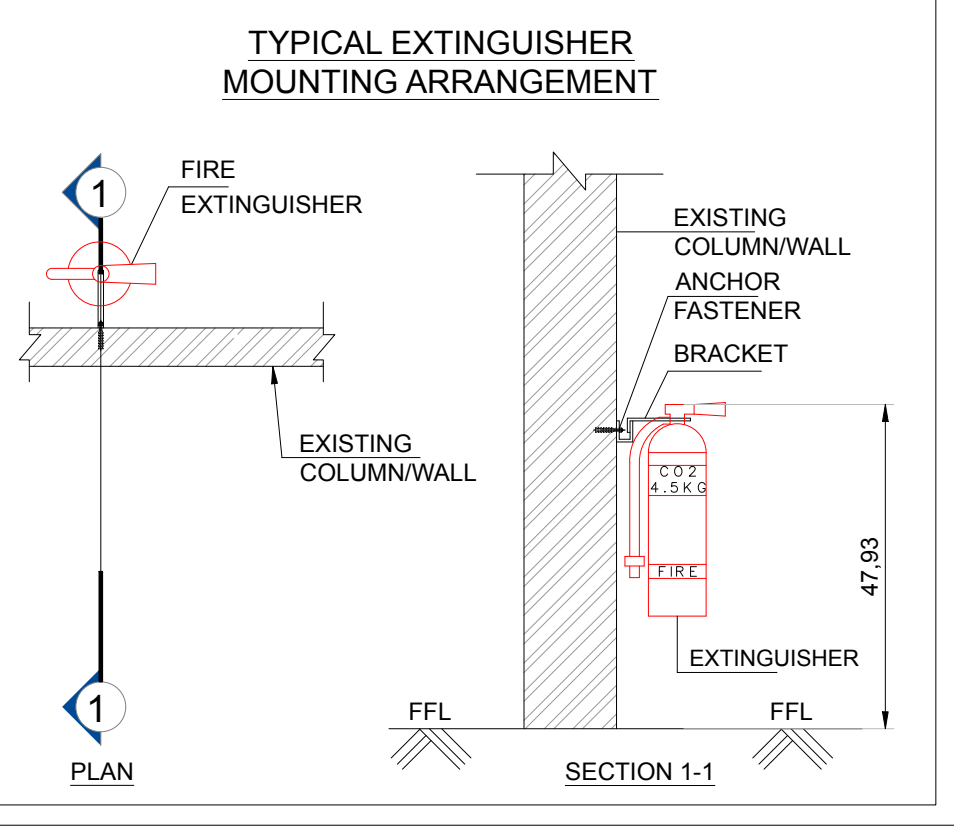

TYPICAL EXTINGUISHER MOUNTING ARRANGEMENT

RED DOTTED LINES FOR HEAT DETECTORS
LIGHT GRAY DOTTED LINES FOR SMOKE DETECTORS NAD MULTI-CRITERIA.

FIRE ALARM SYS LEGEND:-

SYMBOL	DESCRIPTION
	FIRE PANEL-2 ZONE
	MANUAL CALL POINT
	HOOTER CUM STROBE LIGHT, SOUND LEVEL 65 DB OR 5 DB
	RESPONSE INDICATOR FOR ABOVE FALSE CEILING DETECTORS
	SMOKE DETECTOR BELOW FALSE CEILING
	HEAT DETECTOR BELOW FALSE CEILING
	MULTI - CRITERIA DETECTOR ABOVE FALSE CEILING
	FAULT ISOLATOR MODULE
	MONITOR MODULE
	CONTROL MODULE
	FIRE SURVIVAL ARMoured CABLE

MAKE - JOHNSON OR AS DIRECTED

2Cx1.5 sq.mm FRLS PVC SHEATHED ARMORED CABLE FOR FA SYSTEM

NOTE:-HOOTER PANEL & FIRE DETECTION SYSTEM WILL BE LOOPED INDEPENDENTLY ON SEPARATE PANEL

NOTE:-KITCHEN HOOD FIRE SUPPRESSION SYSTEM SHALL BE INTEGRATED WITH FAS. STARTERS FOR KITCHEN EXHAUST AND FRESH AIR SHALL BE INTEGRATED WITH FAS. FIRE ALARM PANEL NOT REQUIRED ALL THE DEVICES SHALL BE LOOPED TO THE JB PROVIDED BY AIRPORT AUTHORITY.

MEPCONSULTANT: **US CONSULTANTS**
C-47, SECOND FL. SECTOR -2, NOIDA - 201301
TEL: +911204206093,4555284
+91 9999 200799
Email: info@usconsultants.in
website: www.usconsultants.in

SITE:
FF-19_HYDERABAD
AIRPORT_International-West



DRAWING TITLE :
FIRE ALARM LAYOUT

MADE BY :- ISHANK **CHECKED BY :-** SATISH

DATE 06th MAY 2024 **RO-04** **FD-01**

SUBWAY
EVERSUB India Pvt Ltd

OFFICE :-
SUBWAY SYSTEMS INDIA PRIVATE LIMITED,
Awfis Space Solutions, 3rd Floor, Tower-B,
Unitech Cyber Park, Grurgram, Haryana,
India-122002.

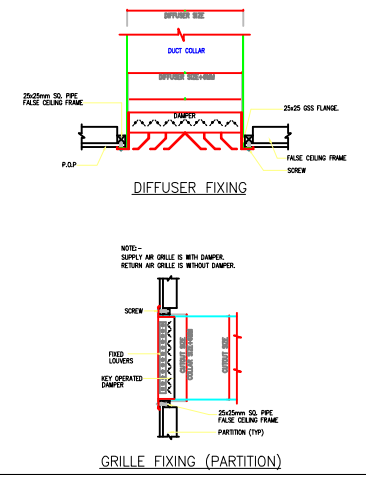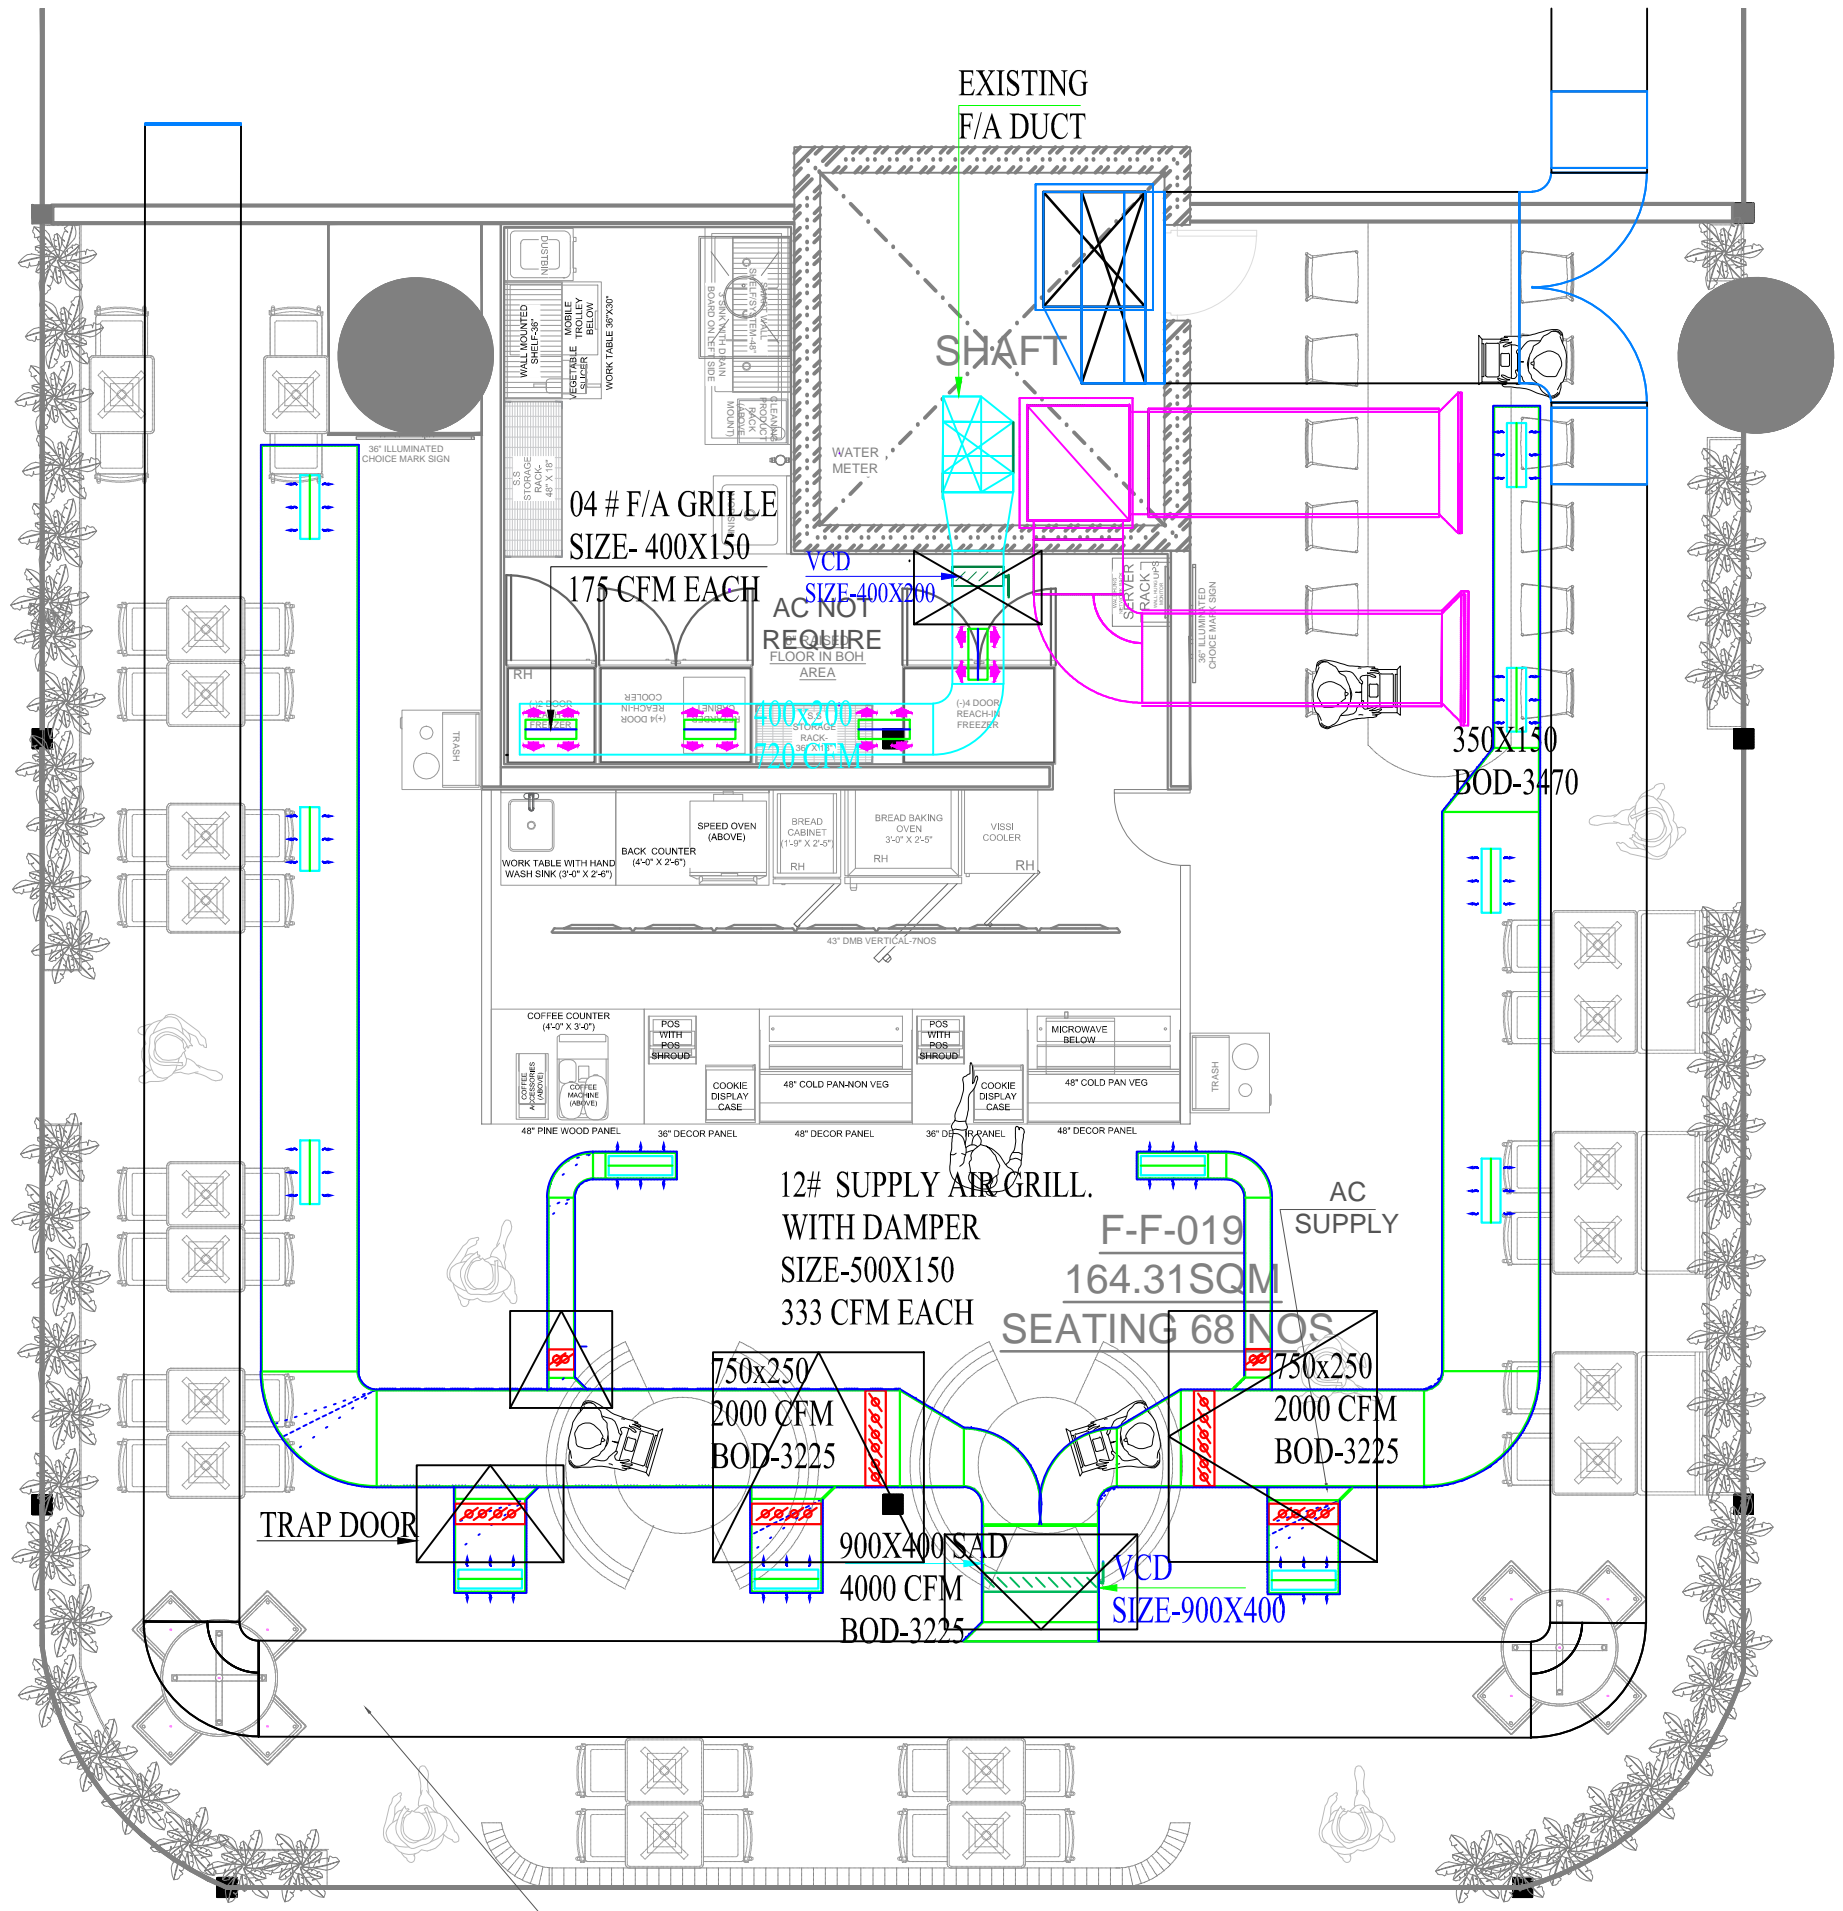

HVAC LEGEND

01		C.S.U UNIT
02		REF. PIPE
03		F/A GRILL
04		E/A GRILL
05		S/A DUCT
06		E/A DUCT
07		F/A DUCT
08		R/A DUCT
09		S/A DIFFUSER
10		R/A DIFFUSER
11		S/A GRILLE
12		V.C.D
13		COLLAR DAMPER
14		DUCT INSULATION
15		TRAP DOOR

MEPCONSULTANT:



US CONSULTANTS
 C-47, SECOND FL.
 SECTOR -2, NOIDA - 201301
 TEL: +911204206093,4555284
 +91 9999 200799
 Email: info@usconsultants.in
 website: www.usconsultants.in

SITE:
 FF-19_HYDERABAD
 AIRPORT_International-West

DRAWING TITLE :
 HVAC LAYOUT

MADE BY :- AQIB CHECKED BY :- SERAJ


DATE | 13 MAY 2024 | RO-01 | AC-01



EVERSUB India Pvt Ltd

OFFICE :-
 SUBWAY SYSTEMS INDIA PRIVATE LIMITED,
 Awfis Space Solutions, 3rd Floor, Tower-B,
 Unitech Cyber Park, Grurgram, Haryana,
 India-122002.

AC

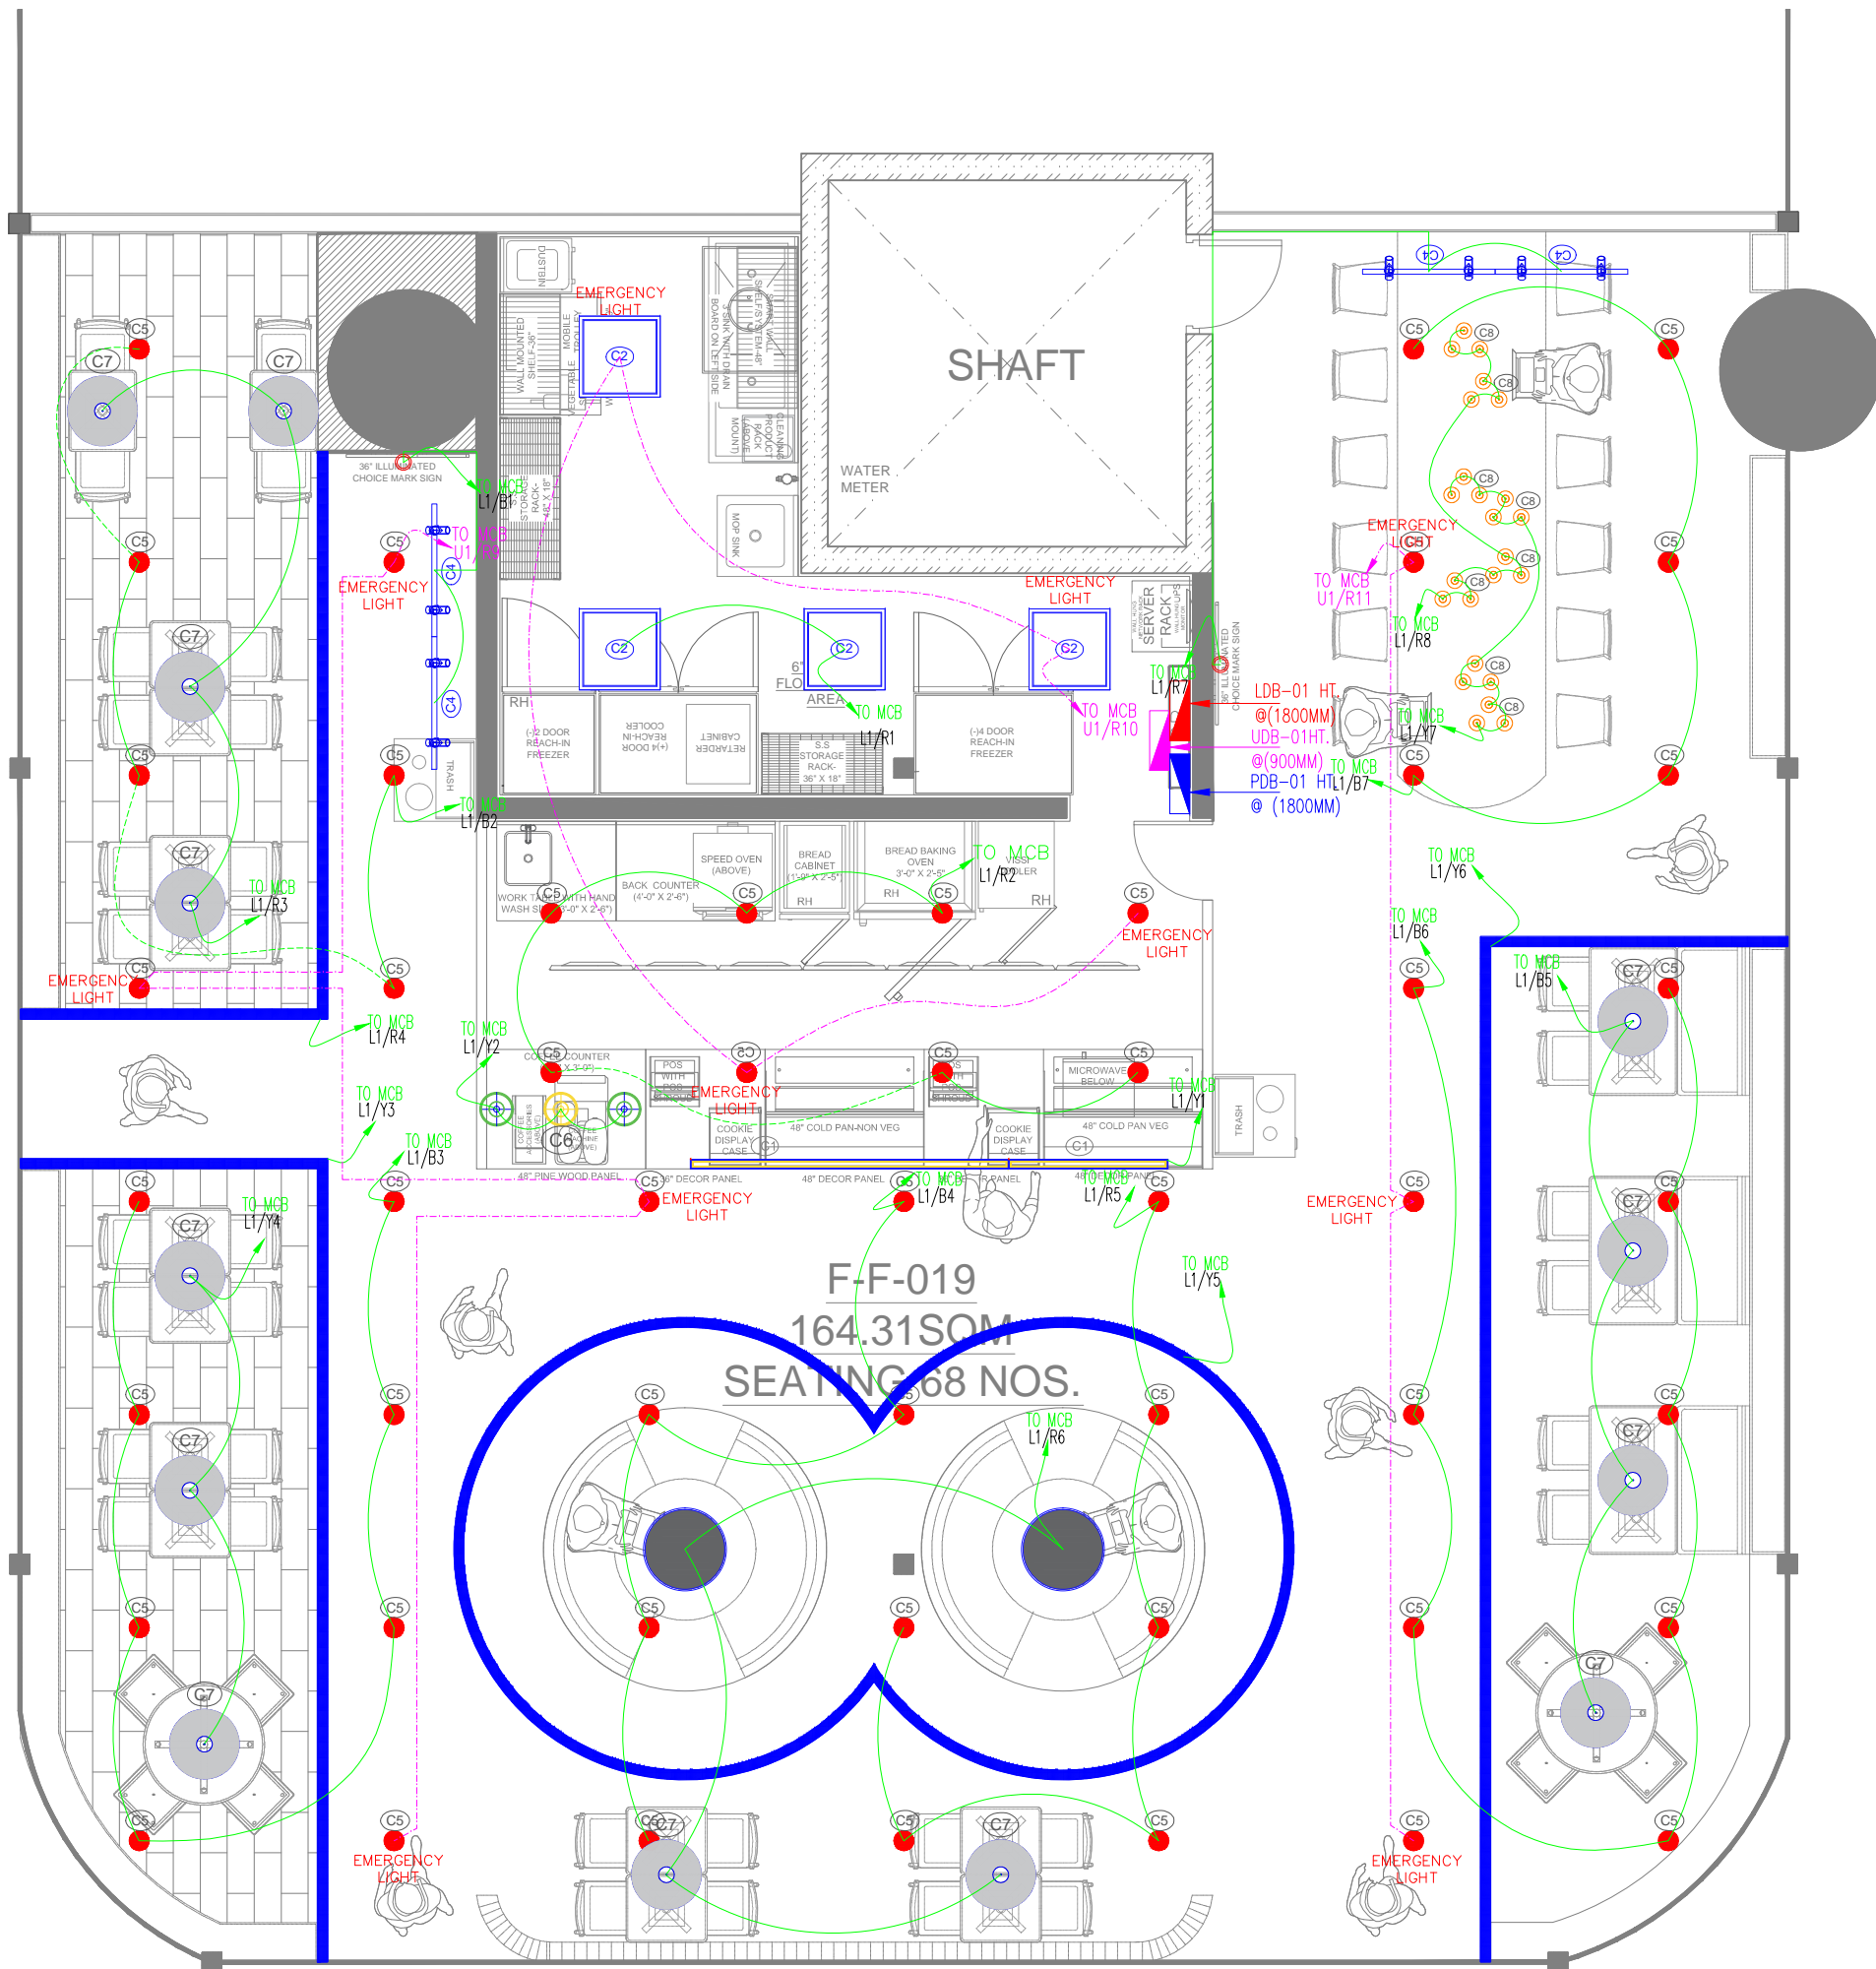

LEGEND DISTRIBUTION BOARD

S.NO.	SYMBOL	DESCRIPTION
1		LIGHT DISTRIBUTION BOARD
2		POWER DISTRIBUTION BOARD
3		LIGHT+POWER DISTRIBUTION BOARD
4		UPS DISTRIBUTION BOARD
5		VTPN DISTRIBUTION BOARD

LIGHT LEGEND:-

S.NO.	SYMBOL	DESCRIPTION
1		SWITCH BOARD FOR NORMAL LIGHT
2		SWITCH BOARD FOR EMERGENCY LIGHT
3		NORMAL LIGHT LOOP
4		EMERGENCY LIGHT LOOP
5		EMERGENCY MARKING

CEILING FIXTURE AND LIGHTING SCHEDULE

IMAGE	#	MODEL	COUNT	DESCRIPTION	WATTAGE	TOTAL WATTS
	C1	SUSPENDED LINEAR CHANNEL LIGHT	1	8' LENGTHS, 72" W, JOINTER & ADDITIONAL STRING REQUIRE (HEIGHT 7' FROM LIGHT TO SLAB)	72	4188
	C1	SUSPENDED LINEAR CHANNEL LIGHT	1	4' LENGTHS, 36" W, JOINTER & ADDITIONAL STRING REQUIRE (HEIGHT 7' FROM LIGHT TO SLAB)	36	
	C2	95X95 MM CEILING LED LIGHT	4	CEILING 38 W LEDLIGHT, 10W, 220-240V, 4000K, 3000 LUMEN OUTPUT.	152	
	C3	115mm RECESSED DOWNLIGHT	0	RECESSED 115mm LED DOWNLIGHT, 18W, 220-240V, 3500K, 1000 LUMEN OUTPUT.	0	
	C4	MINI TL 2-LINE	8	WATTAGE 15W, CCT 3K, LIGHT SOURCE CHREE COB, WITH TRACK COLOUR GRAY POWDER COATED WITH SILVER REFLECTOR.	120	
	C5	Vortex LED	79	WATTAGE 30 W, ALUMINUM BODY POWDER COATED IN BLACK, CLEAN DIFFUSER, HIGH POWER HIGH LUMEN OUTPUT LED, HIGH EFFICIENCY REFLECTOR OPTICAL, EFFECTIVE THERMAL MANAGEMENT	3160	
	C6	PENDANT LIGHT	3	WATTAGE 20W	60	
	C7	HANGING LIGHT	13	WATTAGE 36 WATT 3NOES-108 WATT	468	
	C8	DECORATIVE LIGHT	1	120 WATTAGE	120	

MEPCONSULTANT:

US CONSULTANTS
 C-47, SECOND FL.
 SECTOR -2, NOIDA - 201301
 TEL: +911204206093,4555284
 +91 9999 200799
 Email: info@usconsultants.in
 website: www.usconsultants.in

SITE:
 FF-19_HYDERABAD
 AIRPORT_International-West


DRAWING TITLE :
 LIGHTING LAYOUT

MADE BY :- SHASHANK | CHECKED BY :- SATISH

DATE | 02nd APRIL 2024 | RO-01 | EL-01

EVERSUB India Pvt Ltd

OFFICE :-
 SUBWAY SYSTEMS INDIA PRIVATE LIMITED,
 Awfis Space Solutions, 3rd Floor, Tower-B,
 Unitech Cyber Park, Grurgram, Haryana,
 India-122002.

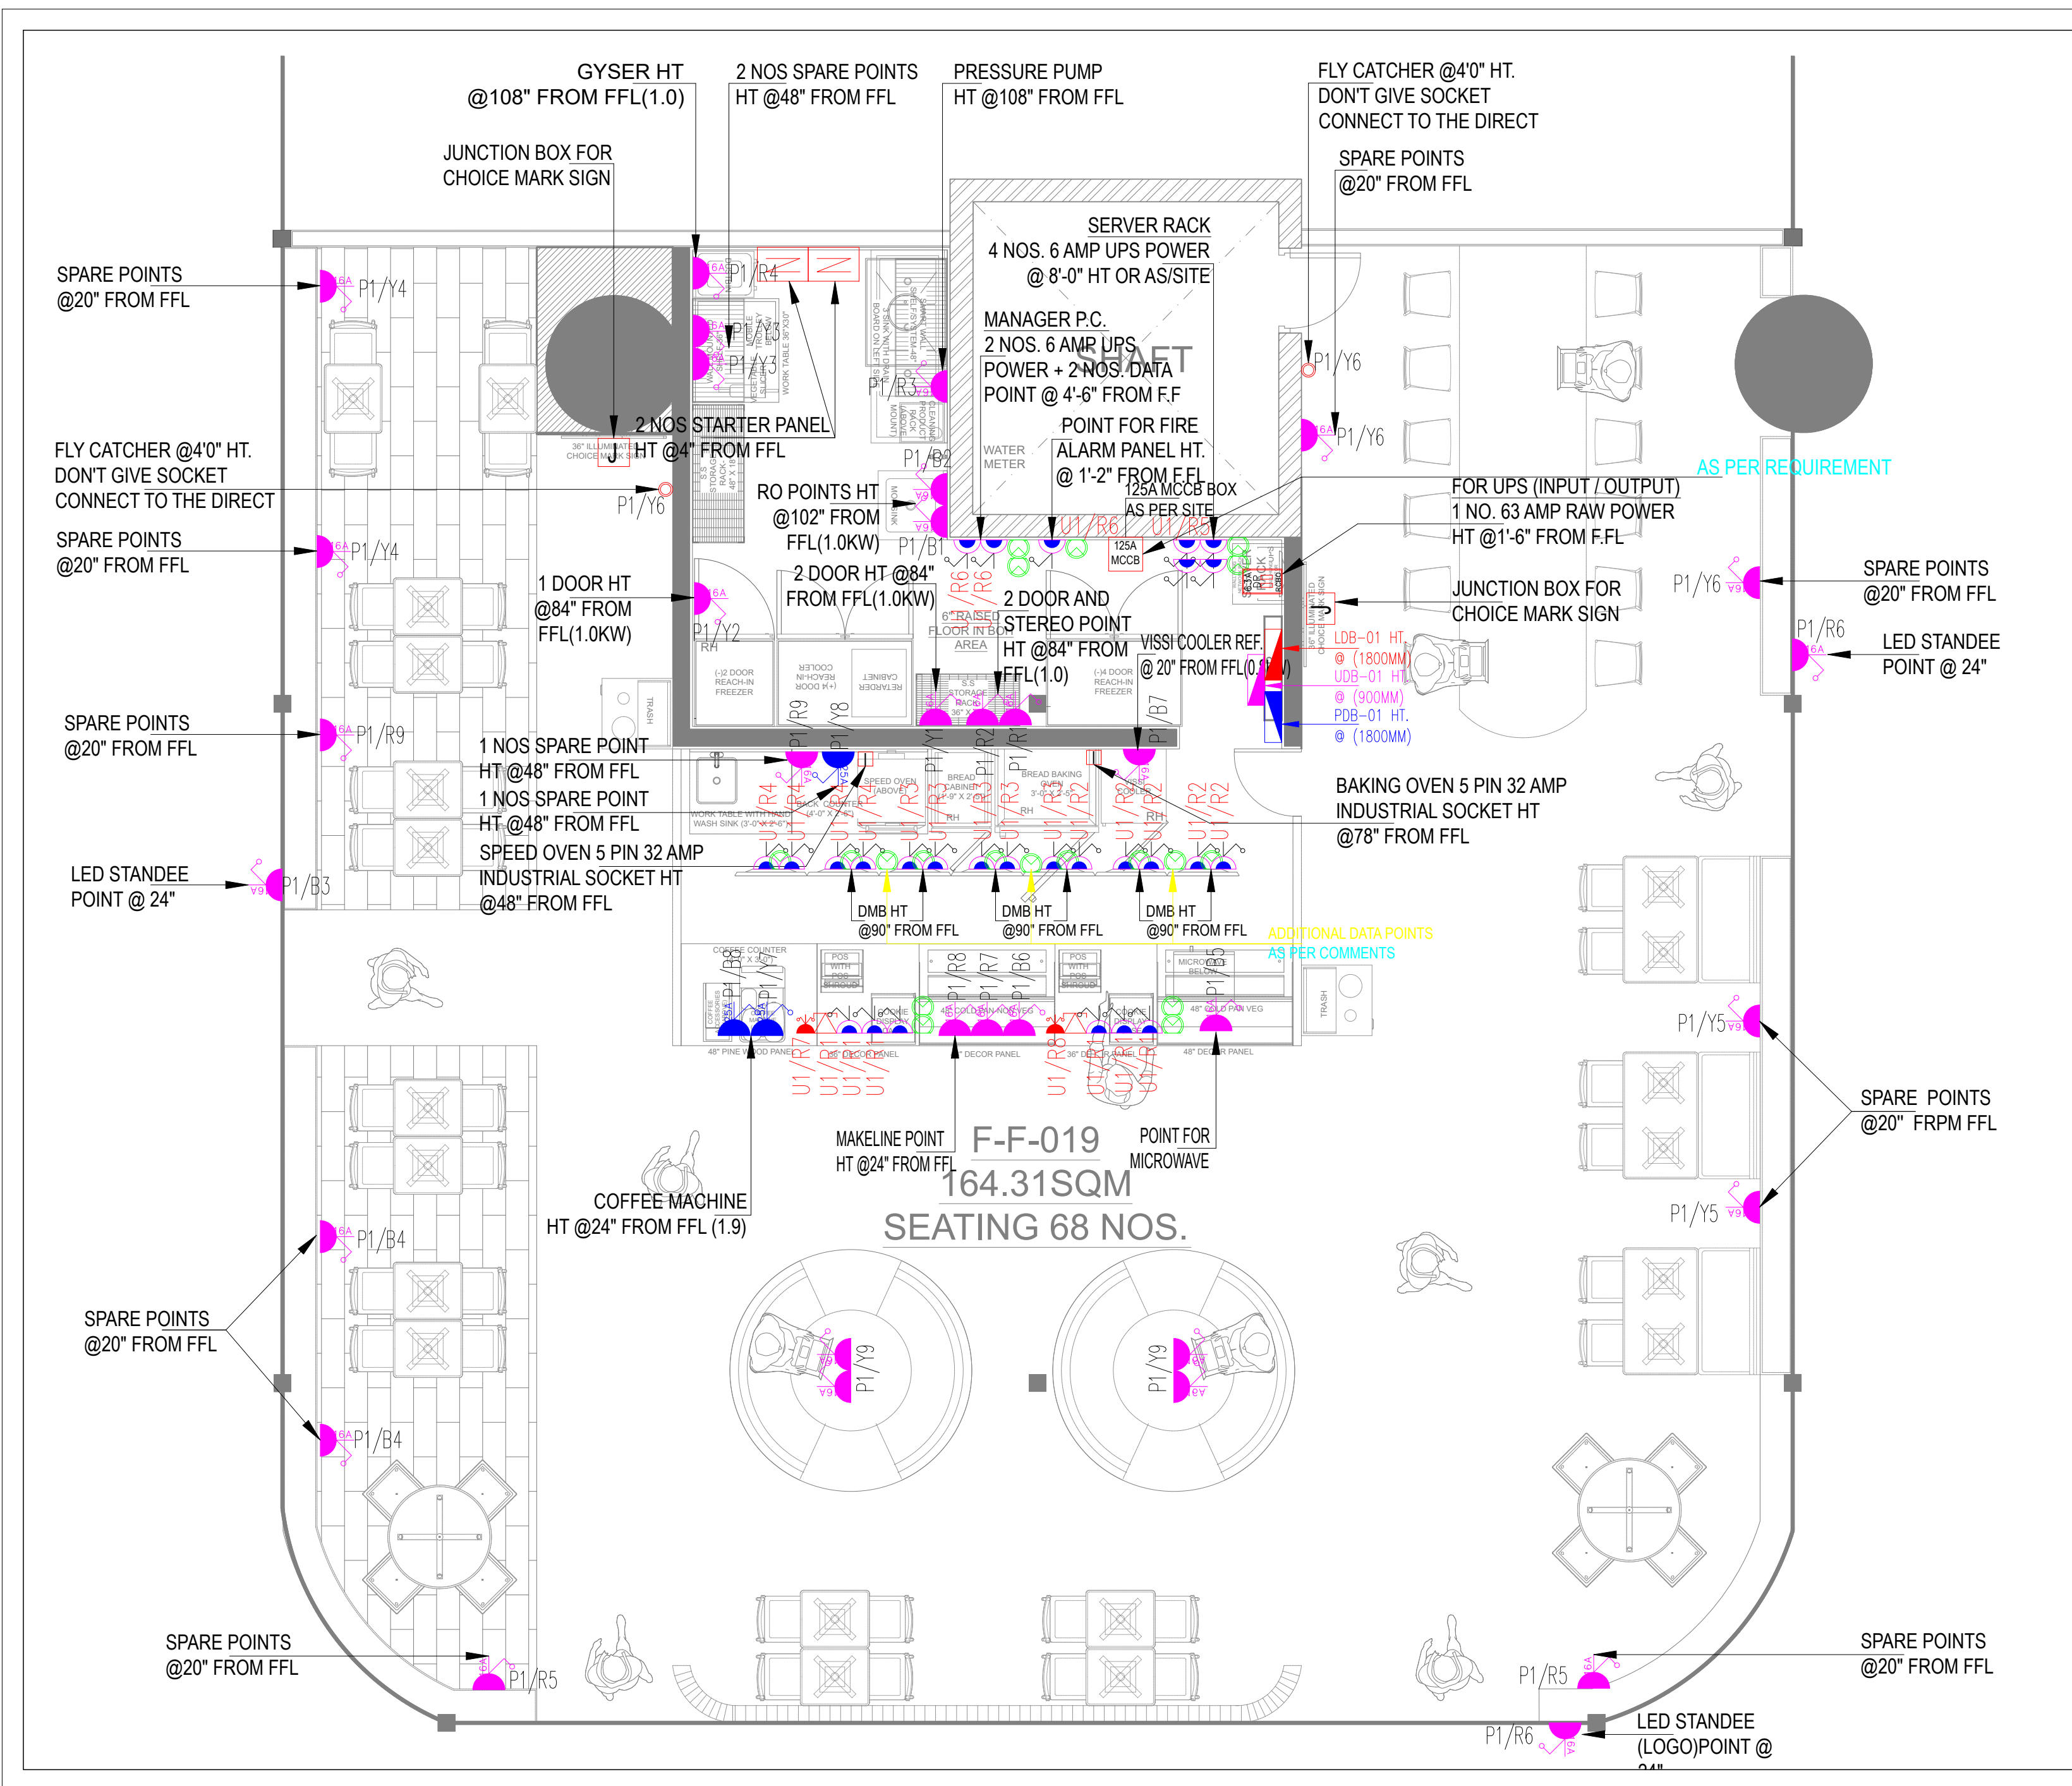

POWER LEGEND:-


SYMBOL	DESCRIPTION
[J]	JUNCTION BOX
[Symbol]	RAW POWER 16A 5PIN SWITCH SOCKET OUTLET, UTLET, 6 Sq.mm Cu Wire
[Symbol]	RAW POWER 25A POWER POINT, 6 Sq.mm Cu Wire
[Symbol]	CAT6 INFORMATION OUTLET
[Symbol]	RJ11 TELEPHONE OUTLET
[Symbol]	UPS POWER 2NO.16A 5PIN SWITCH SOCKET OUTLET
[SB]	LIGHTING SWITCH BOARD
[DB]	DB
[Symbol]	UPS SUPPLY
[Symbol]	AIR CURTAIN
[Symbol]	FLY CATCHER

ALL WIRES BY FRLS WILL BE USED, MS CONDUITS WILL BE USED
 ALL CABLE GLANDS TO BE PROPERLY EARTHED THROUGH STANDARD GLAND RING INTERNALLY AND TO BE TERMINATED AT COMMON EARTH STRIP

LEGEND DISTRIBUTION BOARD

S.NO.	SYMBOL	DESCRIPTION
1	[Symbol]	LIGHT DISTRIBUTION BOARD
2	[Symbol]	POWER DISTRIBUTION BOARD
3	[Symbol]	LIGHT+POWER DISTRIBUTION BOARD
4	[Symbol]	UPS DISTRIBUTION BOARD
5	[Symbol]	VTPN DISTRIBUTION BOARD
6	[Symbol]	STARTER
7	[Symbol]	ISOLATOR BOX

MEPCONSULTANT:



US CONSULTANTS
 C-47, SECOND FL.
 SECTOR -2, NOIDA - 201301
 TEL: +911204206093, 4555284
 +91 9999 200799
 Email: info@usconsultants.in
 website: www.usconsultants.in

SITE:
FF-19_HYDERABAD
AIRPORT_International-West





DRAWING TITLE :
POWER LAYOUT

MADE BY :- ISHANK **CHECKED BY :-** SATISH
DATE 06ND MAY 2024 **RO-02** **EL-02**



EVERSUB India Pvt Ltd

OFFICE :-
SUBWAY SYSTEMS INDIA PRIVATE LIMITED,
Awfis Space Solutions, 3rd Floor, Tower-B,
Unitech Cyber Park, Grurgram, Haryana,
India-122002.

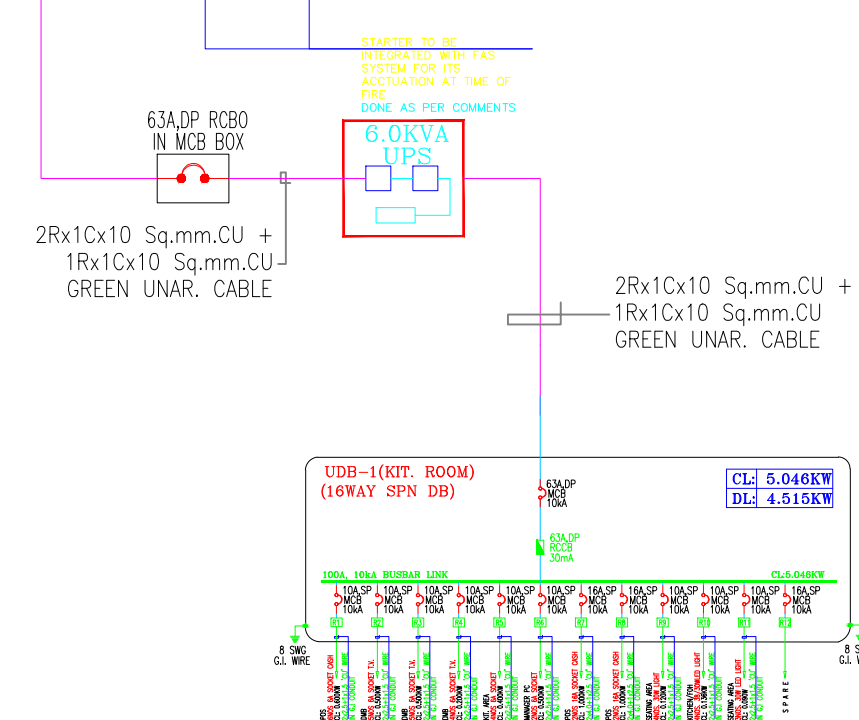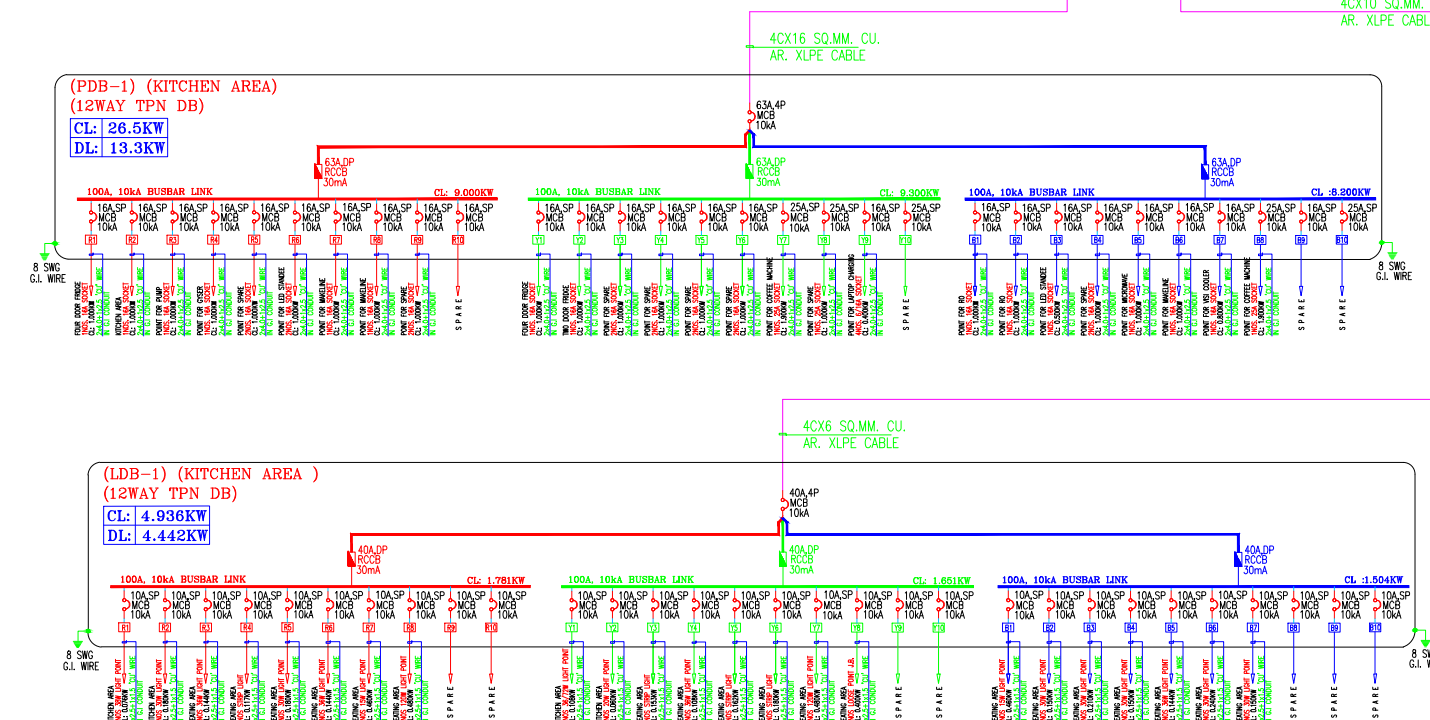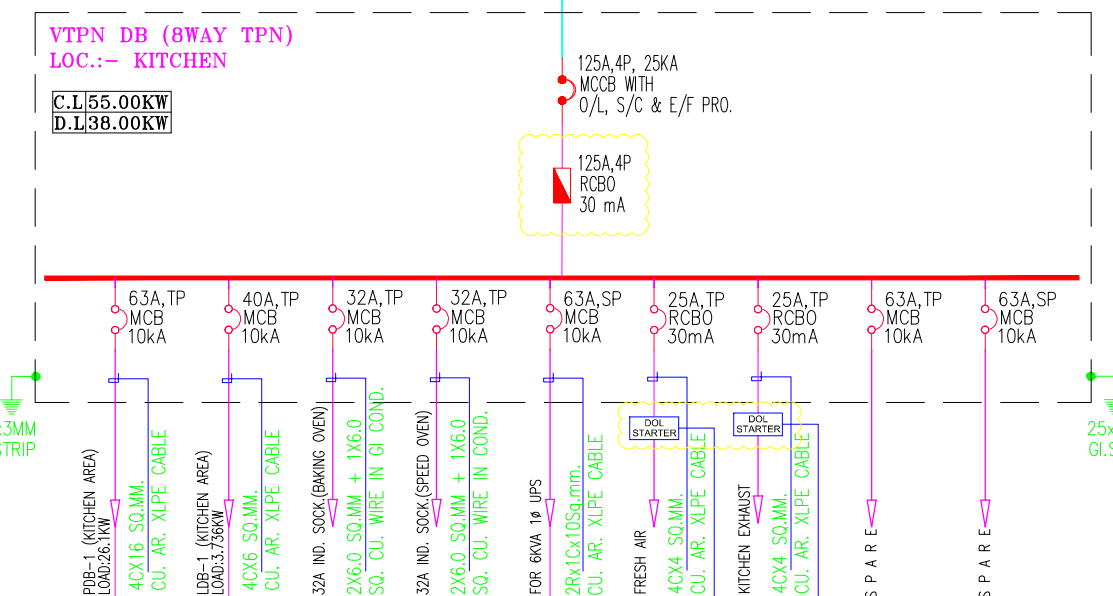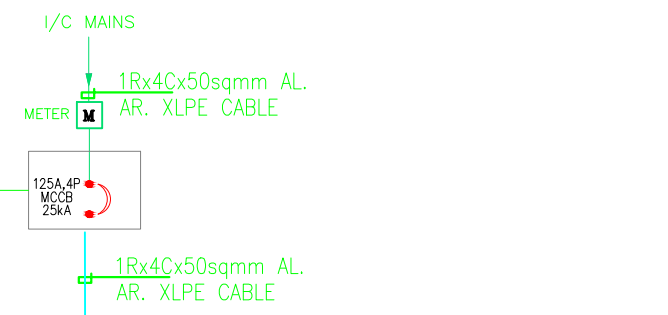

LEGENDS :

ELECTRICAL LEGEND :-

S.NO.	SYMBOL	DESCRIPTION
1		MOULDED CASE CIRCUIT BREAKER
2		MINIATURE CIRCUIT BREAKER
3		RCBO PROTECTION
4		INDICATION LAMP (RED, YELLOW, BLUE)
5		ON/OFF INDICATION LAMP
6		EARTH LEAKAGE RELAY
7		MULTI-FUNCTION METER
8		CURRENT TRANSFORMER
9		AUTO-MANUAL SELECTOR SWITCH
10		CAPACITOR BANK
11		FUSE WITH BASE
12		START/STOP PUSH BUTTON
13		EARTHING

MEP CONSULTANT :

US CONSULTANTS
 C-47, SECOND FL.
 SECTOR -2, NOIDA - 201301
 TEL: +911204206093, 4555284
 +91 9999 200799
 Email: info@usconsultants.in
 website: www.usconsultants.in

SITE:
FF-19_HYDERABAD AIRPORT International-West


DRAWING TITLE :
SLD LAYOUT

MADE BY :- ISHANK
 CHECKED BY :- SATISH

DATE | 22th APRIL 2024 | RO-02 | SL-01

EVERSUB India Pvt Ltd

OFFICE :-
 SUBWAY SYSTEMS INDIA PRIVATE LIMITED,
 Awfis Space Solutions, 3rd Floor, Tower-B,
 Unitech Cyber Park, Grurgram, Haryana,
 India-122002.

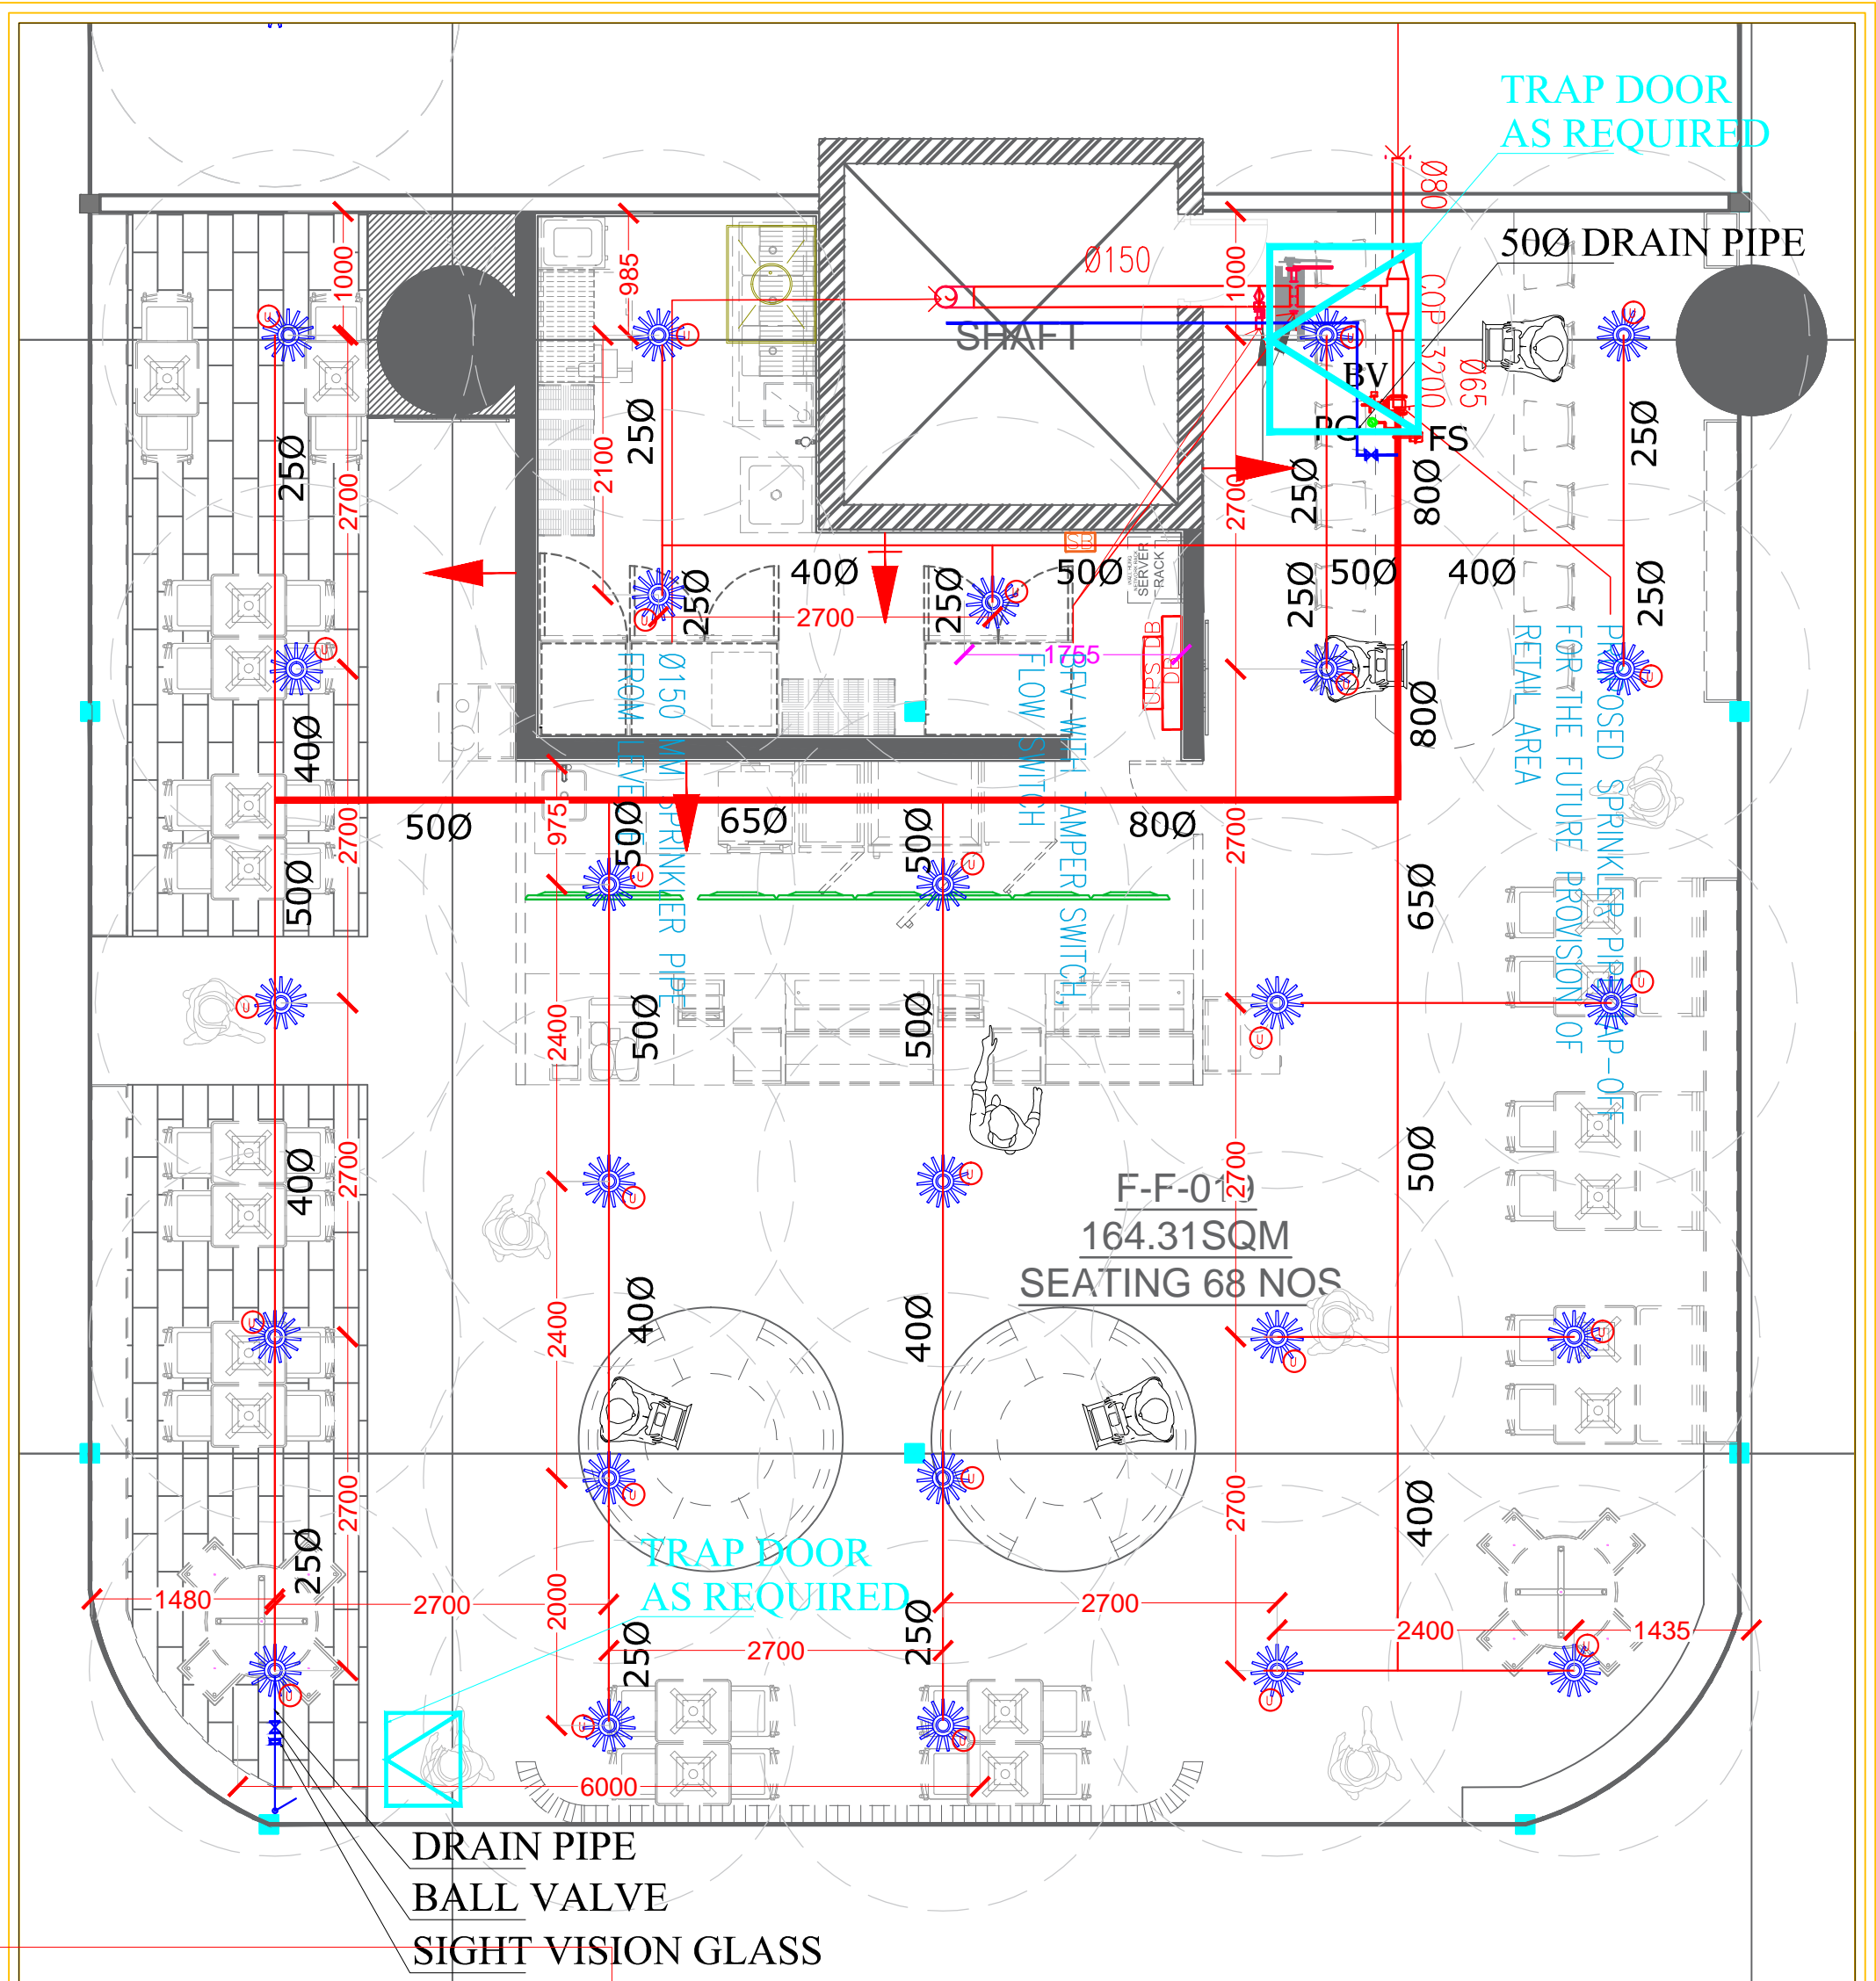

PIPE SCHEDULE	
NO OF SPRINKLER	DIA/SIZE OF PIPE
1-2	250
3	320
4-5	400
6-10	500
11-30	650
31-60	800
61-100	1000
101-ABOVE	1500

Sr.NO.	SYMBOL	DESCRIPTION	TOTAL QTY
1	—	PENDENT SPRINKLER PIPE LINE	
2	☉	UPRIGHT SPRINKLER (Sprinkler should be UL listed and FM approved only) (MAKE- TYCO QUICK RESPON)	26 NOS
3	☀	PENDENT TYPE SPRINKLERS NOZZLE (Sprinkler should be UL listed and FM approved only) (MAKE- TYCO QUICK RESPON)	26 NOS
4	⋈	BUTTERFLY VALVE / ISOLATION VALVE (MAKE-AUDCO PN-16)	1 NO
5	⋈	FLOW SWITCH	1 NO
6	⋈	PRESSURE GAUGE (Use Diaphragm Type)	1 NO
7	⋈	BALL VALVE	1 NO
8	—	DRAIN LINE	
9	⋈	6 KG ABC DRY POWDER PORTABLE FIRE EXTINGUISHER	3 NOS
10	⋈	2 KG ABC DRY POWDER PORTABLE FIRE EXTINGUISHER	1 NO

- NOTE -**
- 1) SPRINKLER POINT ON EVERY FACADE - SPRINKLER DISTANCE NOT MORE THAN 600MM FORM FACADE
 - 2) PRESSURE GAUGE - (USE DIAPHRAGM TYPE) USE GLYCERINE TYPE PRESSURE GAUGE ONLY WITH NECESSARY ASSEMBLY.
 - 3) SPRINKLER LINE HYDROSTATIC PRESSURE TESTING TO BE DONE AT 13.8 BAR FOR 48 HRS. IT MUST BE CHECKED & CERTIFIED BY MALL ERT. CERTIFICATE TO BE SUBMITTED AFTER CONFIRMATION.
 - 4) PIPE SIZE (BELOW 25MM PIPE SHOULD NOT BE USED FOR SPRINKLER POINT.
 - 5) SPRINKLER SYSTEM NEEDS TO BE EXECUTED AS PER IS 15105 (C-CLASS IS 1239)
 - 6) SPRINKLER TO BE CONNECTED TO MALL SYSTEM THRU A BUTTERFLY VALVE. THIS VALVE SHOULD BE KEPT ON 14/7 AND SHOULD BE ACCESSIBLE FOR CHECKING THROUGH A TRAP DOOR OF ADEQUATE.
 - 7) DUE TO SITE AND DESIGN CONDITION IF THE BUTTERFLY VALVE IS NOT REACHABLE FROM THE ABOVE PROVIDED TRAP DOOR (MORE THEN 3FEET FROM TRAP DOOR), THEN A METAL PLATFORM NEEDS TO BE PROVIDED OF ADEQUATE SIZE , FOR SOMEONE TO STEP UP AND REACH THE VALVE.
 - 8) One Sprinkler for 120 SQFT OR 10 SQMT- Common area sprinkler red colour rating is 68 degree-
"i gY"; = #AG : 171 7@5GG: djdY'cb nI
 - 9) Butt welded sockets to be used.
 - 10) Sprinkler / GI/MS PIPE - TDS to be provided
 - 11) Sprinkler / GI/MS PIPE - Make provided
 - 12) kitchens- Yellow coloured bulb-sprinkler head to be provided in the kitchen area
 - 13) Sprinklers required in every enclosed space such as storeroom, fitting room, enclosed window displays etc. Upright sprinklers mandatory if gap above false ceiling is more than 800mm. However, if utility /services is placed inside false ceiling sprinkler is required even the gap is less than 800 mm. If duct, lights, tray is falling under sprinkler, sprinkler must be clear from all utilities.

SITE:
FF-19_HYDERABAD
AIRPORT_International-West


DRAWING TITLE:
SPRINKLER LAYOUT

MADE BY: AASTHA

DATE: 10TH JAN 2024 RO 07

SUBWAY
EVERSUB India Pvt Ltd

OFFICE -
SUBWAY SYSTEMS INDIA PRIVATE
LIMITED.
Awfs Space Solutions, 3rd Floor, Tower-B,
Unitech Cyber Park, Grurgram, Haryana,
India-122002

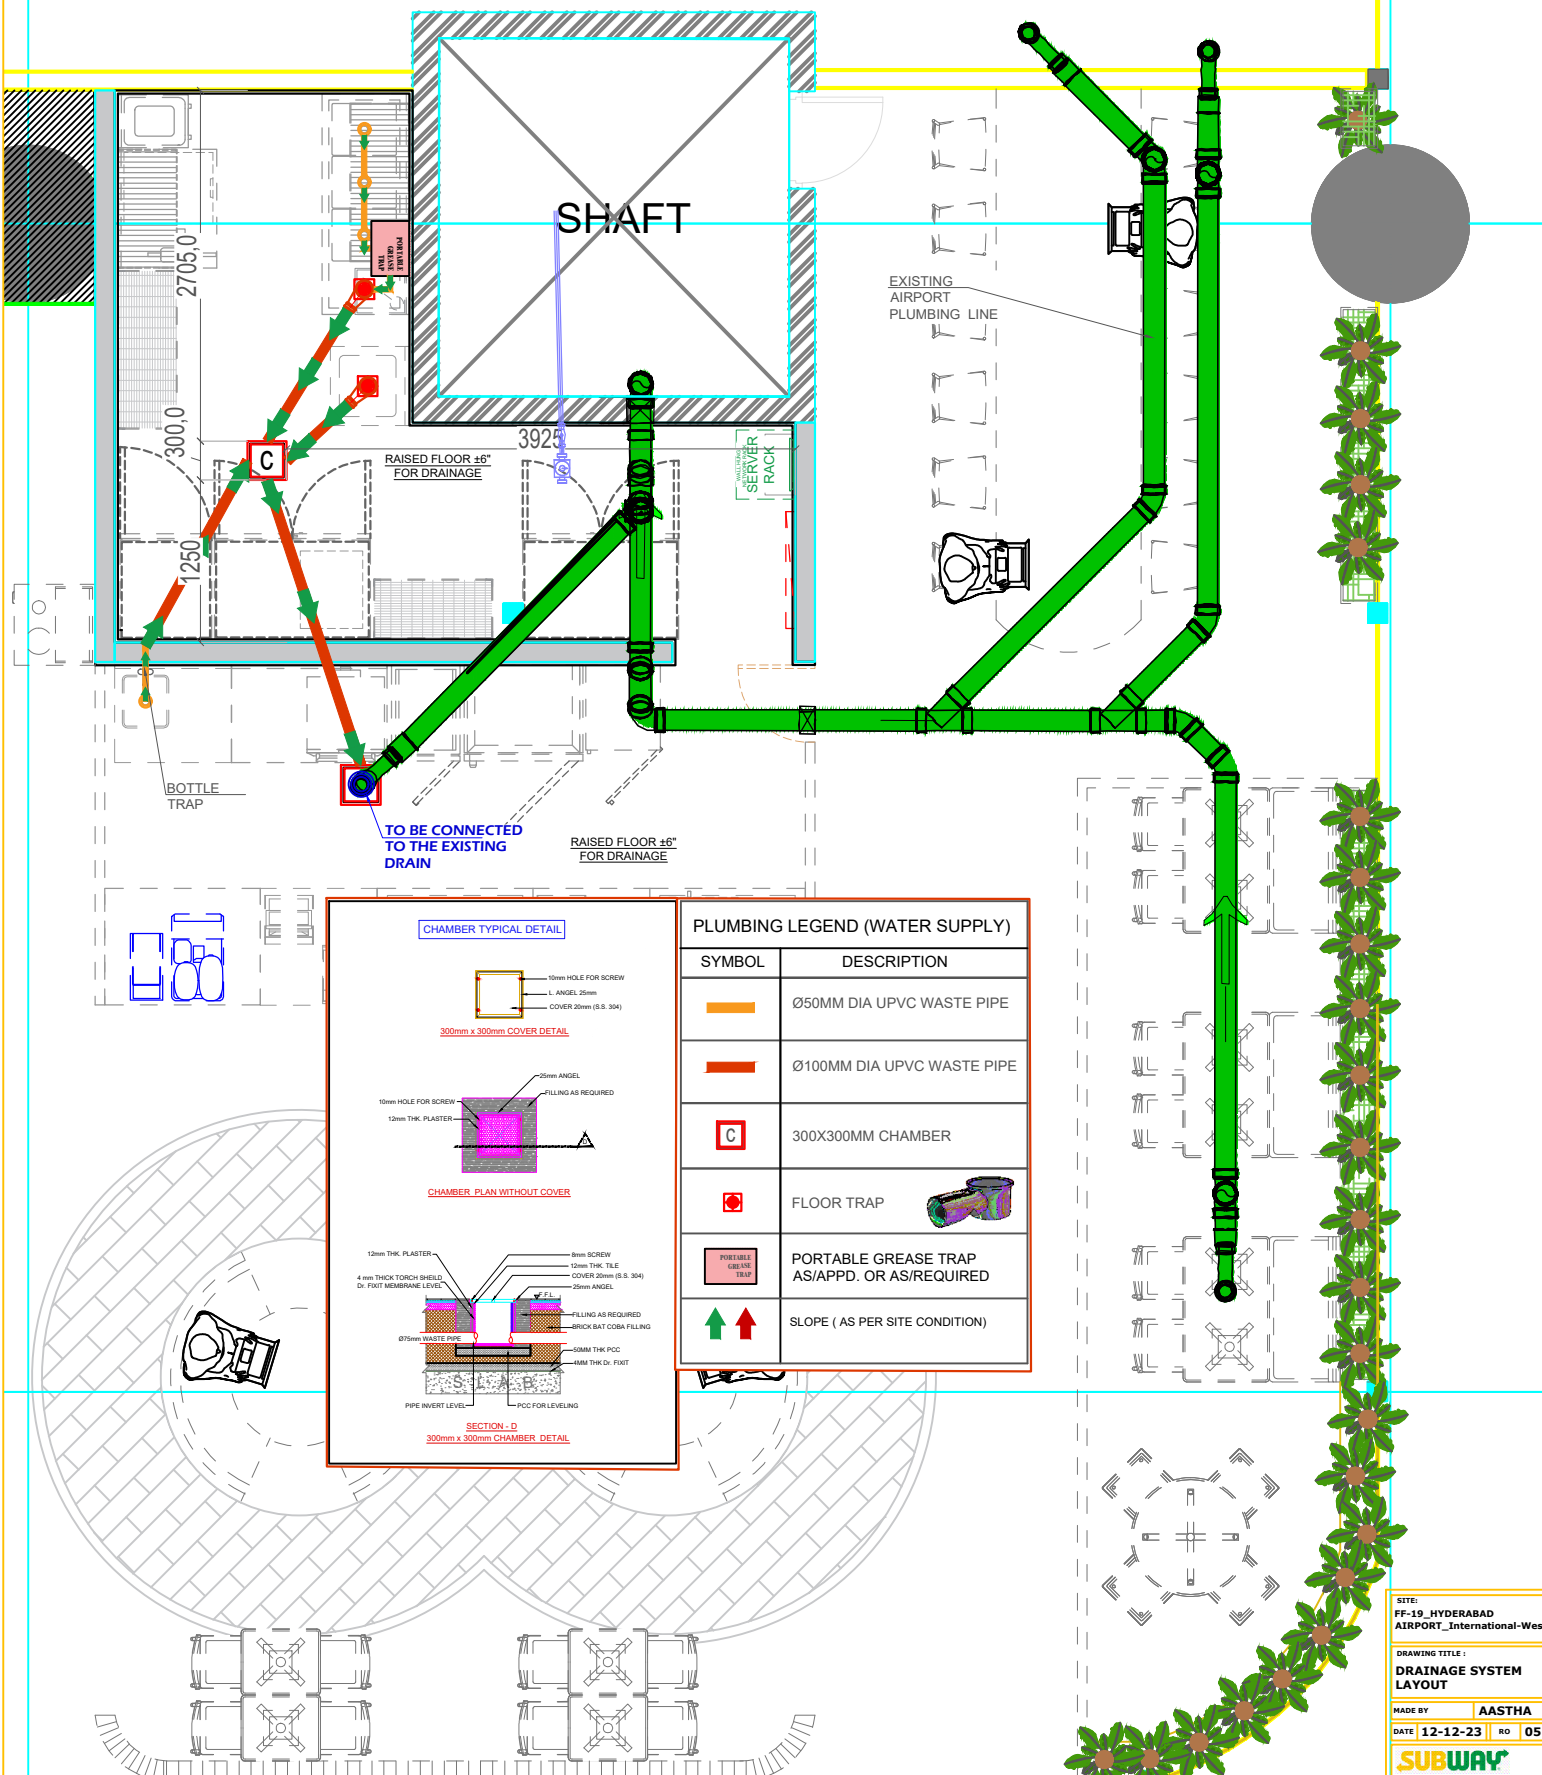

CHAMBER TYPICAL DETAIL

300mm x 300mm COVER DETAIL

CHAMBER PLAN WITHOUT COVER

SECTION - D
300mm x 300mm CHAMBER DETAIL

PLUMBING LEGEND (WATER SUPPLY)

SYMBOL	DESCRIPTION
	Ø50MM DIA UPVC WASTE PIPE
	Ø100MM DIA UPVC WASTE PIPE
	300X300MM CHAMBER
	FLOOR TRAP
	PORTABLE GREASE TRAP AS/APPD. OR AS/REQUIRED
	SLOPE (AS PER SITE CONDITION)