

WOW MOMO & WOW CHINA  
AT AHMEDABAD AIRPORT  
FOOD COURT, GUJARAT.


GFC BY;  
ARCH THINK STUDIO

FLAT NO-13 DDA SFS SLAT POCKET -1 SEC-6 DWARKA,  
NEW DELHI-110075 EMAIL:-infoatats@gmail.com  
OFF-011-35559249, MOB:9910315171



**WOW MOMO & WOW CHINA AT AHMEDABAD AIRPORT  
FOOD COURT, GUJARAT.**

S.NO.	DRAWING NAME	DRAWING NUMBER	NO. OF DRAWINGS
<b>A</b>	<b>PLAN</b>		
1	EQUIPEMENT LAYOUT	IA-101	1
2	EQUIPEMENT DIM. LAYOUT	IA-102	1
3	CIVIL WORKING PLAN	IA-103	1
4	WATER PROOFING LAYOUT	IA-104	1
5	FLOORING LAYOUT	IA-105	1
6	WALL ELECTRICAL LAYOUT	IA-106	1
7	WATER SUPPLY LAYOUT	IA-107	1
8	DRAINAGE LAYOUT	IA-108	1
9	REFLECTED CEILING PLAN	IA-109	1
10	LIGHTING LAYOUT LAYOUT	IA-110	1
11	WALL FINISHING LAYOUT	IA-111	1
12	GAS ROUTING LAYOUT	IA-112	1
13	CCTV LAYOUT	IA-113	1
14	SPRINKLER LAYOUT	IA-114	1
15	SMOKE DETECTOR LAYOUT	IA-115	1
16	HVAC LAYOUT	IA-116	1
17	FIRE EVACUATION LAYOUT	IA-117	1
18	COORDINATED LAYOUT	IA-118	1
19	SINGLE LINE DIAGRAM(SLD)	IA-119	1
20	LOAD SHEET		
<b>B</b>	<b>INTERNAL ELEVATIONS</b>		
21	SECTIONAL DEMARCATION LAYOUT	IA-200	1
22	FRONT ELEVATION	IA-201	1
23	SECTIONAL ELEVATION -A-D	IA-202 A-D	4
24	BRANDING ELEVATION -A & B	IA-203	1
<b>C</b>	<b>DETAILS</b>		
25	COUNTER DETAIL & TYPICAL (W/M - W/C)	IA-300	1

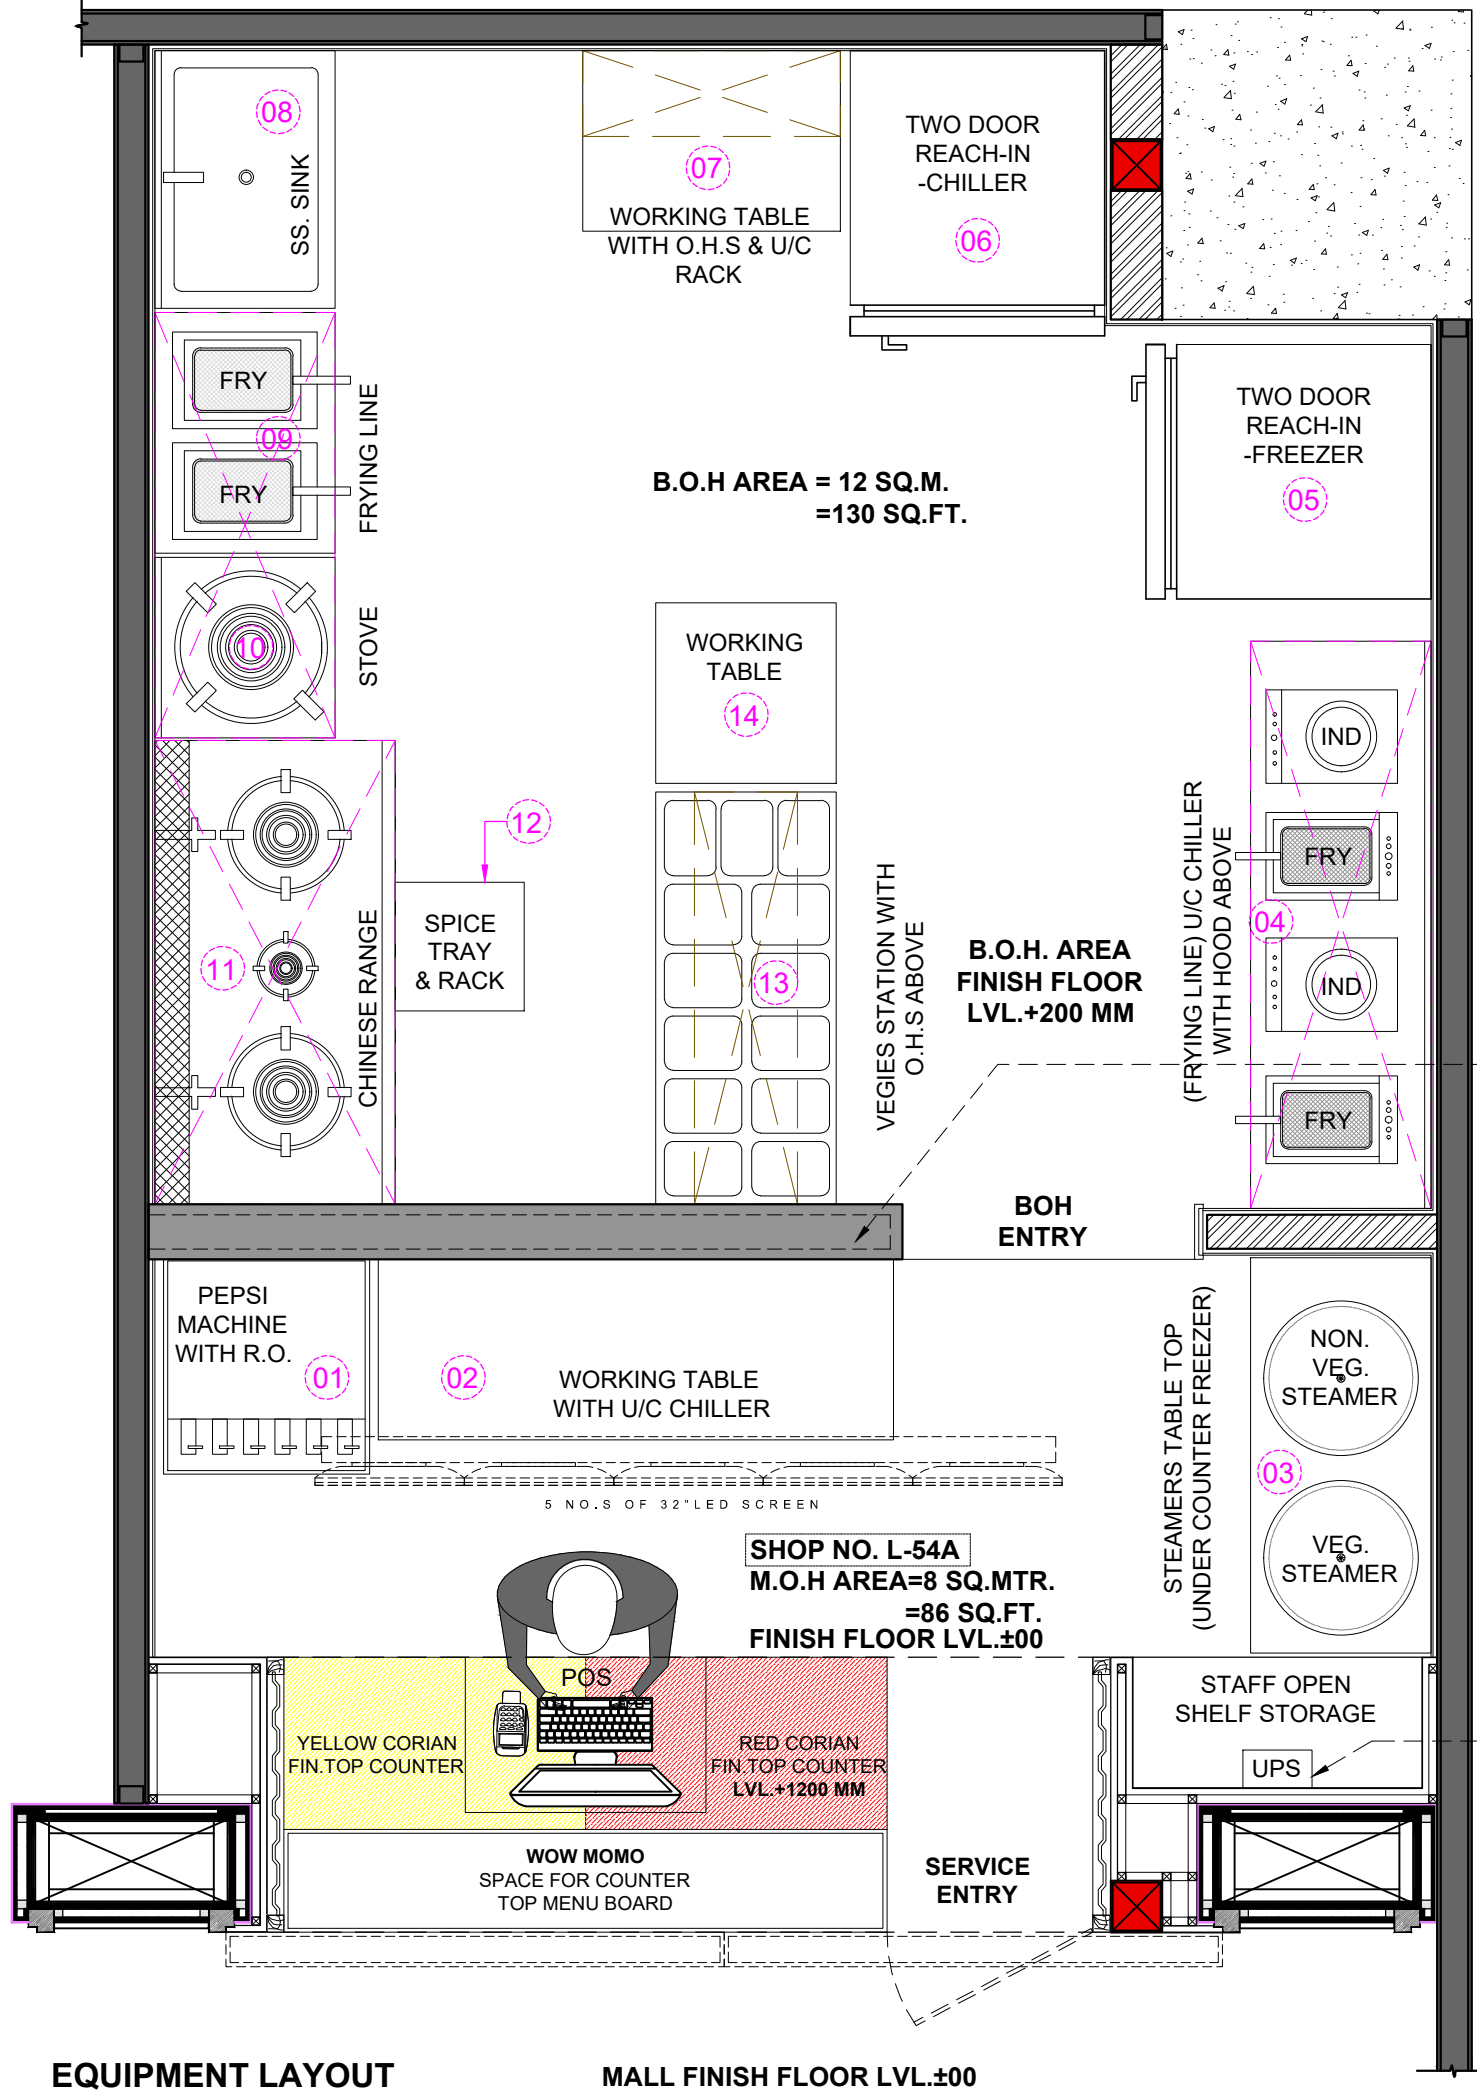

**WOW MOMO & CHINA EQUIPMENT LEGEND :-**

CODE	DESCRIPTION	QTY.	SIZE (MM)
①	PEPSI MACHINE WITH R.O.	ONE	600X625X850 MM
②	WORKING TABLE WITH U/C CHILLER	ONE	1500X525X850 MM
③	STEAMERS TABLE TOP (UNDER COUNTER FREEZER)	ONE	1150X525X850 MM
④	FRYING TABLE WITH UNDER COUNTER CHILLER WITH HOOD ABOVE	ONE	1650X525X850 MM
⑤	TWO DOOR REACH-IN-FREEZER	ONE	840X730X1950 MM
⑥	TWO DOOR REACH-IN-CHILLER	ONE	840X730X1950 MM
⑦	WORKING TABLE WITH U/C SHELF & O.H.S RACK	ONE	750X525X850 MM
⑧	SS. SINK	ONE	750X525X850 MM
⑨	FRYING LINE TABLE	ONE	700X525X850 MM
⑩	STOVE	ONE	525X525X850 MM
⑪	CHINESE RANGE WITH HOOD ABOVE	ONE	1350X700X850 MM
⑫	SPICE TRAY RACK (3 SIDE COVER AND SHELVE ABOVE)	ONE	375X375X850 MM
⑬	VEGIES STATION WITH O.H.S ABOVE	ONE	1200X525X850 MM
⑭	WORKING TABLE	ONE	525X525X850 MM

12 MM THK. GREY CORIAN FIN.TOP ON LOW HT. WALL LVL+1225 MM FROM MOH. FINISH FLOOR LVL.

UPS UNDER STAFF STORAGE

**PROJECT**

WOW MOMO & WOW CHINA @ AHMEDABAD AIRPORT FOOD COURT, GUJARAT.

**CLIENT**  
WOW MOMO & WOW CHINA

**NOTE:**


THIS DRAWING & DESIGN IS THE COPYRIGHT OF THE DESIGNER. NO PORTION MAY BE REPRODUCED WITHOUT THE WRITTEN PERMISSION OF THE DESIGNERS

1. ALL DIMENSIONS ARE INCLUDING FINISHES
2. DO NOT SCALE DRAWING. ONLY MENTIONED DIMENSIONS ARE TO BE CONSIDERED.
3. ALL DIMENSIONS MUST BE CHECKED BEFORE COMMENCING WORK ON SITE.
4. ANY DISCREPANCIES SHALL BE BROUGHT UNDER THE NOTICE OF ARCHITECTS PRIOR COMMENCEMENT OF WORK.

**REVISION**

S.NO.	REMARKS	DATE
1	REV 1	.....
2	REV 2	
3	REV 3	
4	REV 4	
5	REV 5	
6	REV 6	
7	REV 7	
8	REV 8	

**ARCHITECT / INTERIOR DESIGN**

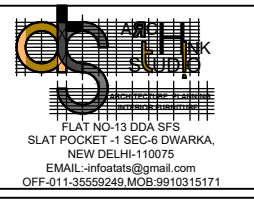

**CONSULTANT**

**CONSULTANT**

**RELEASE FOR**

INFORMATION	TENDER	CONSTRUCTION	AS BUILT

**TITLE**

EQUIPMENT LAYOUT

DATE	03/11/2023
SCALE	N.T.S.
DRAWN BY	VEDPAL
CHECKED BY	RR.
PRINTED BY	.....
DWG. NO.	IA-101

**EQUIPMENT LAYOUT**

MALL FINISH FLOOR LVL.±00

**WOW MOMO & CHINA EQUIPMENT LEGEND :-**

CODE	DESCRIPTION	QTY.	SIZE (MM)
①	PEPSI MACHINE WITH R.O.	ONE	600X625X850 MM
②	WORKING TABLE WITH U/C CHILLER	ONE	1500X525X850 MM
③	STEAMERS TABLE TOP (UNDER COUNTER FREEZER)	ONE	1150X525X850 MM
④	FRYING TABLE WITH UNDER COUNTER CHILLER WITH HOOD ABOVE	ONE	1650X525X850 MM
⑤	TWO DOOR REACH-IN-FREEZER	ONE	840X730X1950 MM
⑥	TWO DOOR REACH-IN-CHILLER	ONE	840X730X1950 MM
⑦	WORKING TABLE WITH U/C SHELF & O.H.S RACK	ONE	750X525X850 MM
⑧	SS. SINK	ONE	750X525X850 MM
⑨	FRYING LINE TABLE	ONE	700X525X850 MM
⑩	STOVE	ONE	525X525X850 MM
⑪	CHINESE RANGE WITH HOOD ABOVE	ONE	1350X700X850 MM
⑫	SPICE TRAY RACK (3 SIDE COVER AND SHELVE ABOVE)	ONE	375X375X850 MM
⑬	VEGIES STATION WITH O.H.S ABOVE	ONE	1200X525X850 MM
⑭	WORKING TABLE	ONE	525X525X850 MM

**PROJECT**  
 WOW MOMO & WOW CHINA  
 @ AHMEDABAD AIRPORT  
 FOOD COURT, GUJARAT.

**CLIENT**  
 WOW MOMO & WOW CHINA


**NOTE:**  
 THIS DRAWING & DESIGN IS THE COPYRIGHT OF THE DESIGNER. NO PORTION MAY BE REPRODUCED WITHOUT THE WRITTEN PERMISSION OF THE DESIGNERS

1. ALL DIMENSIONS ARE INCLUDING FINISHES
2. DO NOT SCALE DRAWING. ONLY MENTIONED DIMENSIONS ARE TO BE CONSIDERED.
3. ALL DIMENSIONS MUST BE CHECKED BEFORE COMMENCING WORK ON SITE.
4. ANY DISCREPANCIES SHALL BE BROUGHT UNDER THE NOTICE OF ARCHITECTS PRIOR COMMENCEMENT OF WORK.

**REVISION**

S.NO.	REMARKS	DATE
1	REV 1	.....
2	REV 2	
3	REV 3	
4	REV 4	
5	REV 5	
6	REV 6	
7	REV 7	
8	REV 8	

**ARCHITECT / INTERIOR DESIGN**



FLAT NO-13 DDA SFS  
 SLAT POCKET -1 SEC-6 DWARKA,  
 NEW DELHI-110075  
 EMAIL:-infoatats@gmail.com  
 OFF-011-35559249, MOB-9910315171

**CONSULTANT**  
 \_\_\_\_\_


**CONSULTANT**  
 \_\_\_\_\_

**RELEASE FOR**

INFORMATION	TENDER	CONSTRUCTION	AS BUILT

**TITLE**  
 EQUIPMENT DIM. LAYOUT

DATE	03/11/2023
SCALE	N.T.S.
DRAWN BY	VEDPAL
CHECKED BY	RR.
PRINTED BY	.....
DWG. NO.	IA-102

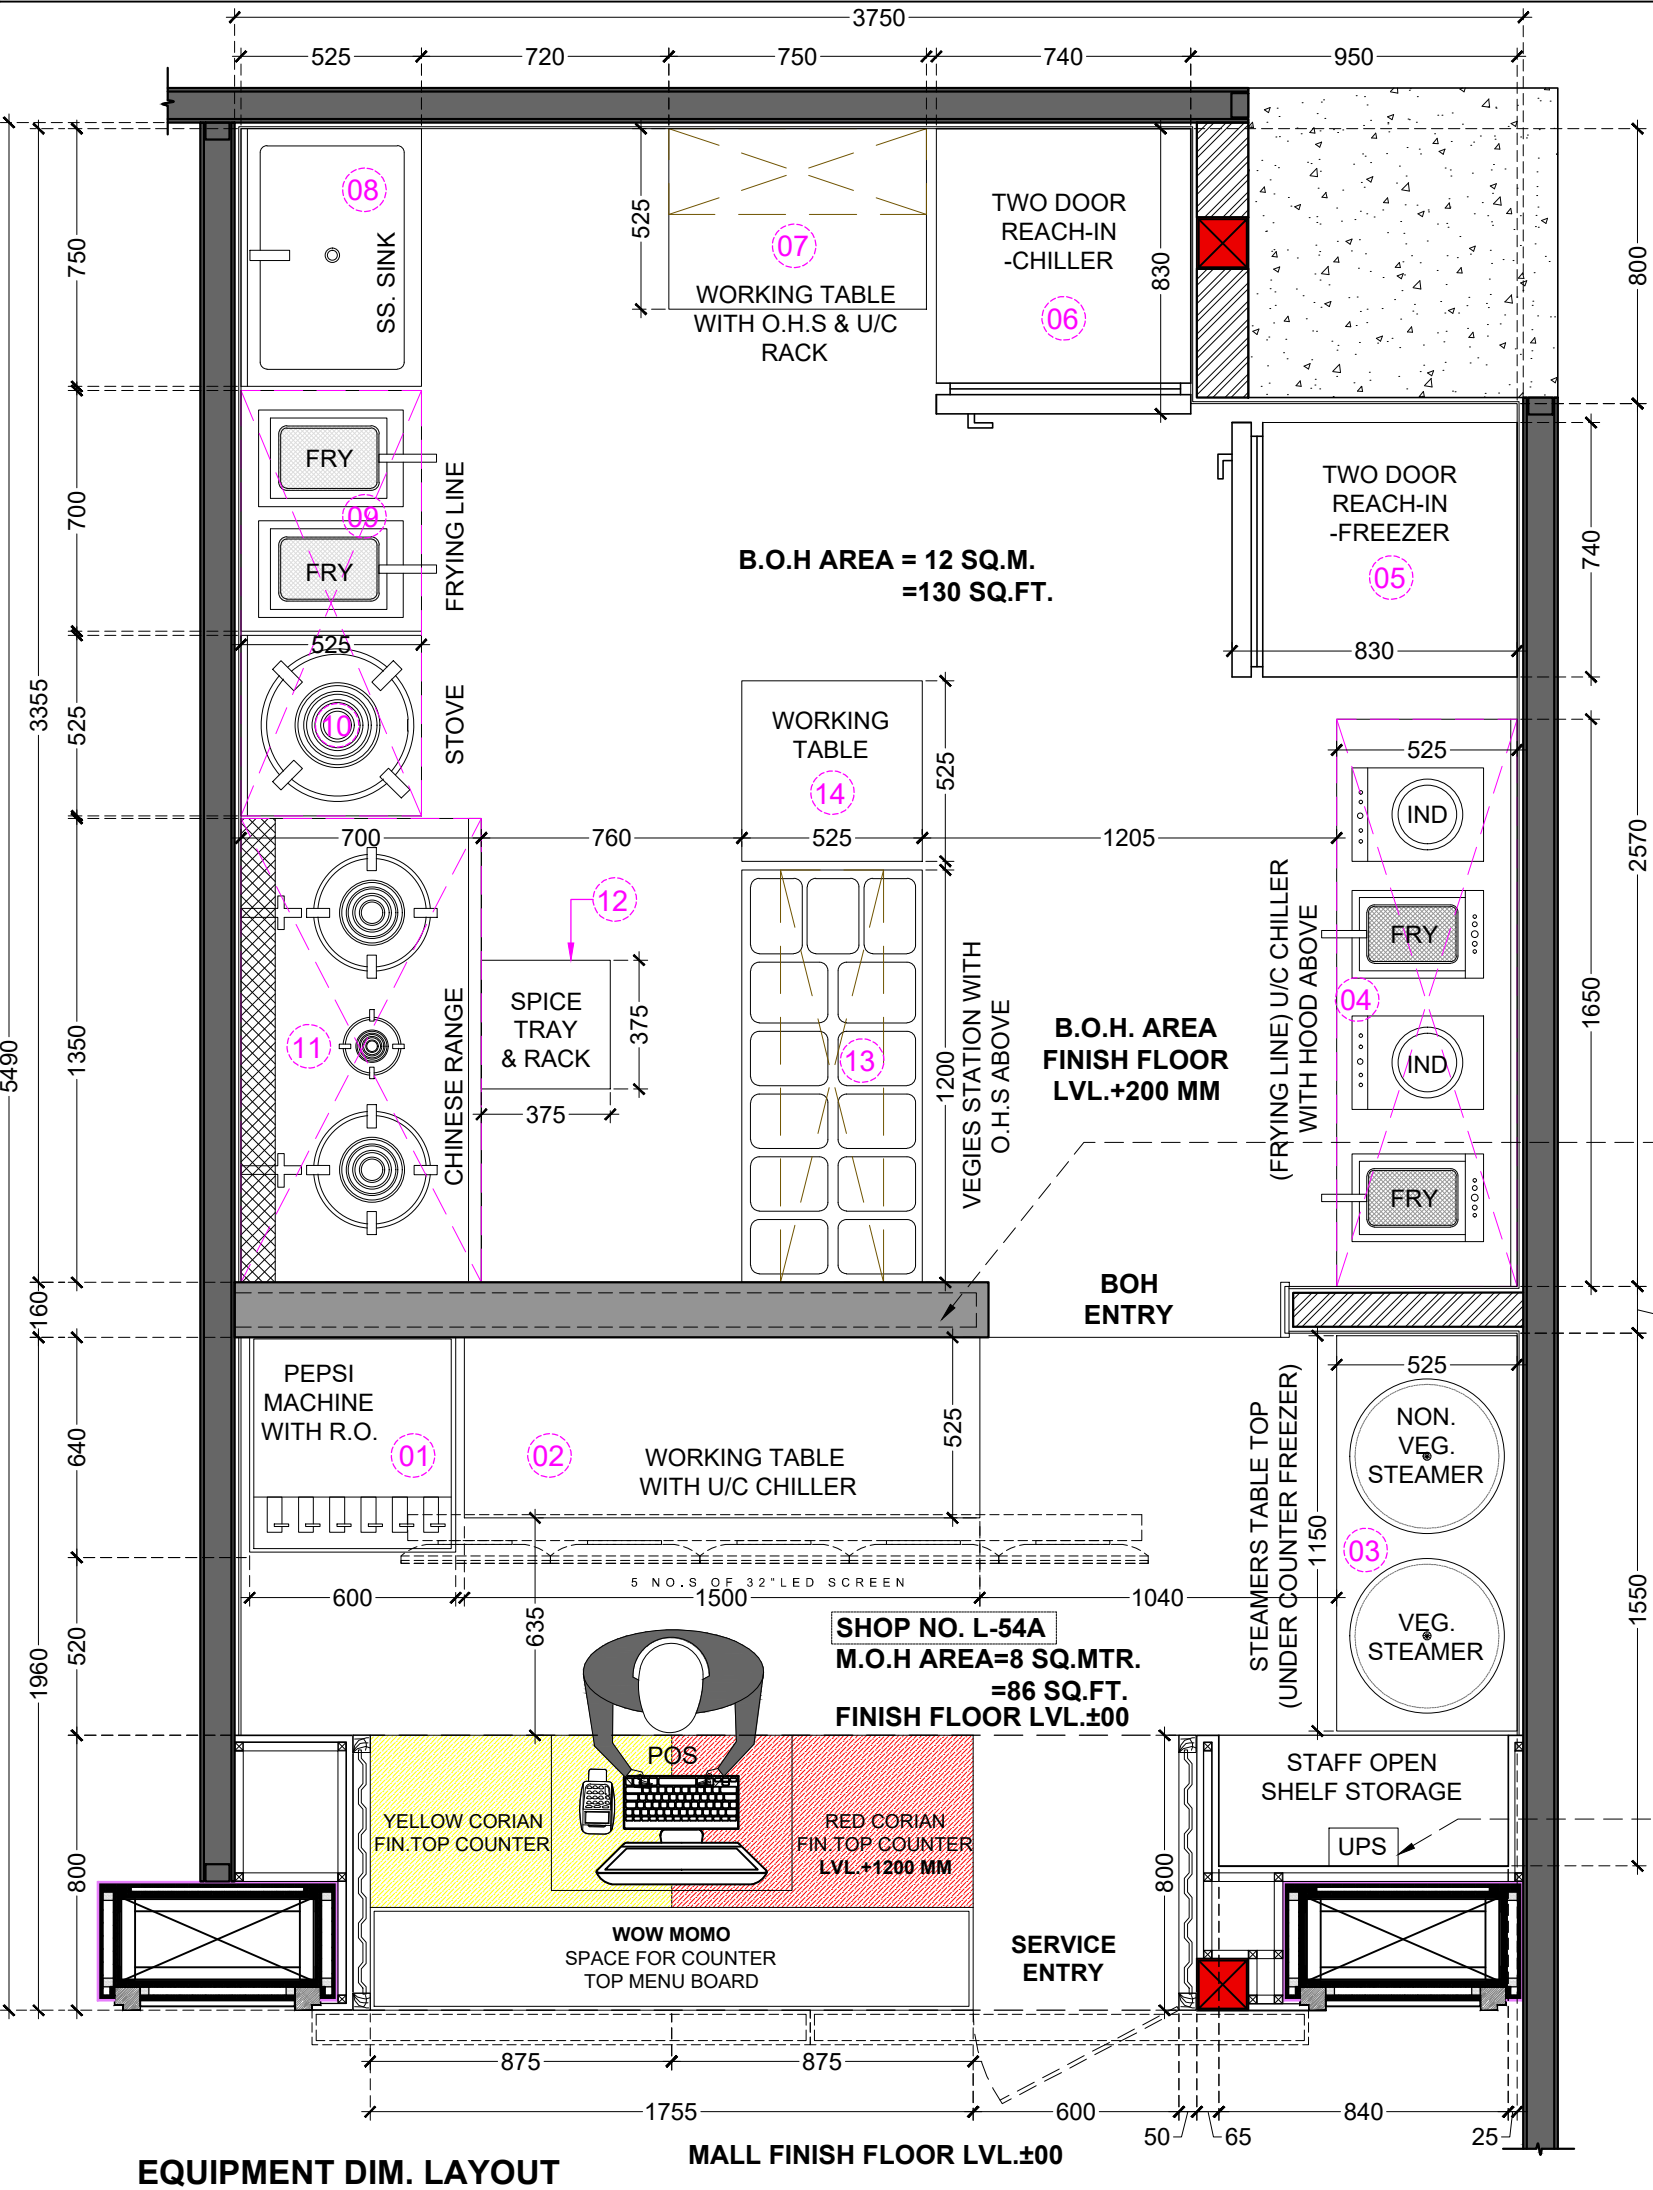


12 MM THK. GREY CORIAN  
 FIN.TOP ON LOW HT. WALL  
 LVL+1225 MM FROM MOH.  
 FINISH FLOOR LVL.

UPS UNDER  
 STAFF STORAGE

**EQUIPMENT DIM. LAYOUT**

MALL FINISH FLOOR LVL.±00

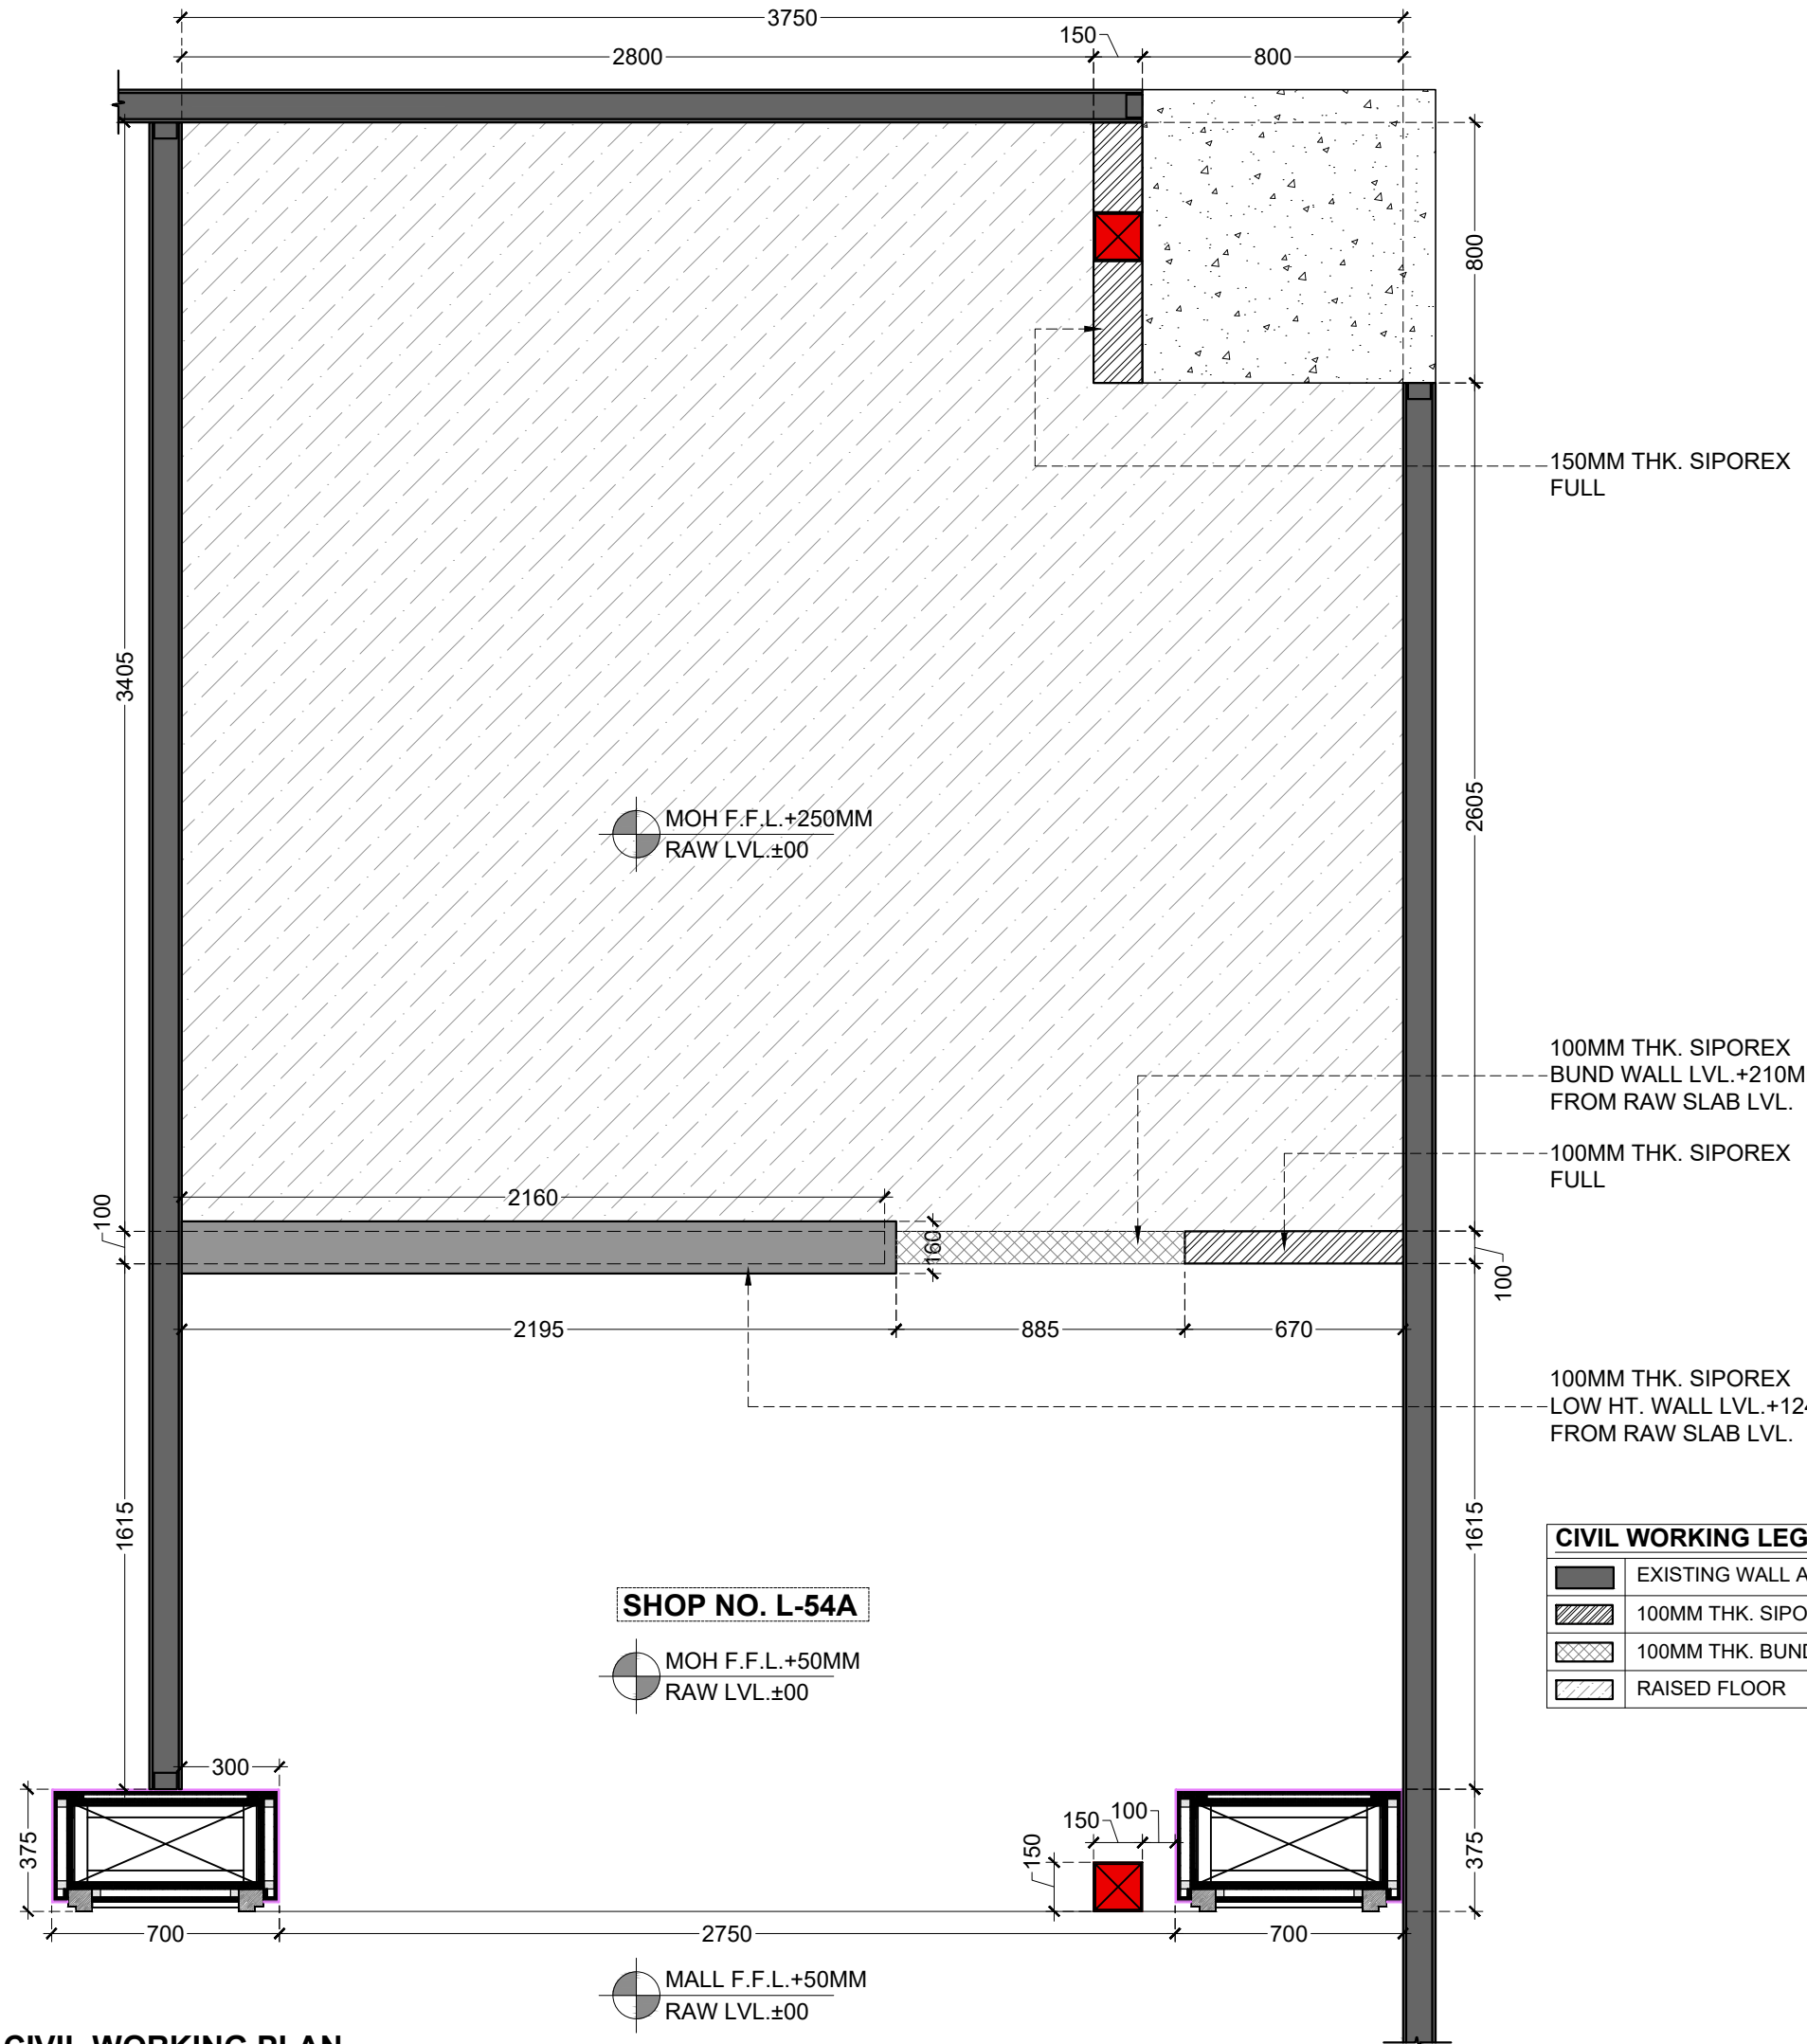

**PROJECT**  
 WOW MOMO & WOW CHINA  
 @ AHMEDABAD AIRPORT  
 FOOD COURT, GUJARAT.

**CLIENT**  
 WOW MOMO & WOW CHINA

**NOTE:**  
 THIS DRAWING & DESIGN IS THE COPYRIGHT OF THE DESIGNER. NO PORTION MAY BE REPRODUCED WITHOUT THE WRITTEN PERMISSION OF THE DESIGNERS

1. ALL DIMENSIONS ARE INCLUDING FINISHES
2. DO NOT SCALE DRAWING. ONLY MENTIONED DIMENSIONS ARE TO BE CONSIDERED.
3. ALL DIMENSIONS MUST BE CHECKED BEFORE COMMENCING WORK ON SITE.
4. ANY DISCREPANCIES SHALL BE BROUGHT UNDER THE NOTICE OF ARCHITECTS PRIOR COMMENCEMENT OF WORK.

**REVISION**

S.NO.	REMARKS	DATE
1	REV 1	
2	REV 2	
3	REV 3	
4	REV 4	
5	REV 5	
6	REV 6	
7	REV 7	
8	REV 8	

**ARCHITECT / INTERIOR DESIGN**

FLAT NO-13 DDA SFS  
 SLAT POCKET -1 SEC-6 DWARKA,  
 NEW DELHI-110075  
 EMAIL: infoatats@gmail.com  
 OFF-011-35559249, MOB:9910315171

**CONSULTANT**  
 \_\_\_\_\_

**CONSULTANT**  
 \_\_\_\_\_


**RELEASE FOR**

INFORMATION	TENDER	CONSTRUCTION	AS BUILT


**TITLE**  
 CIVIL WORKING PLAN

DATE	04/10/2023
SCALE	1:25
DRAWN BY	VEDPAL
CHECKED BY	RR.
PRINTED BY	_____
DWG. NO.	IA-103

**CIVIL WORKING PLAN**

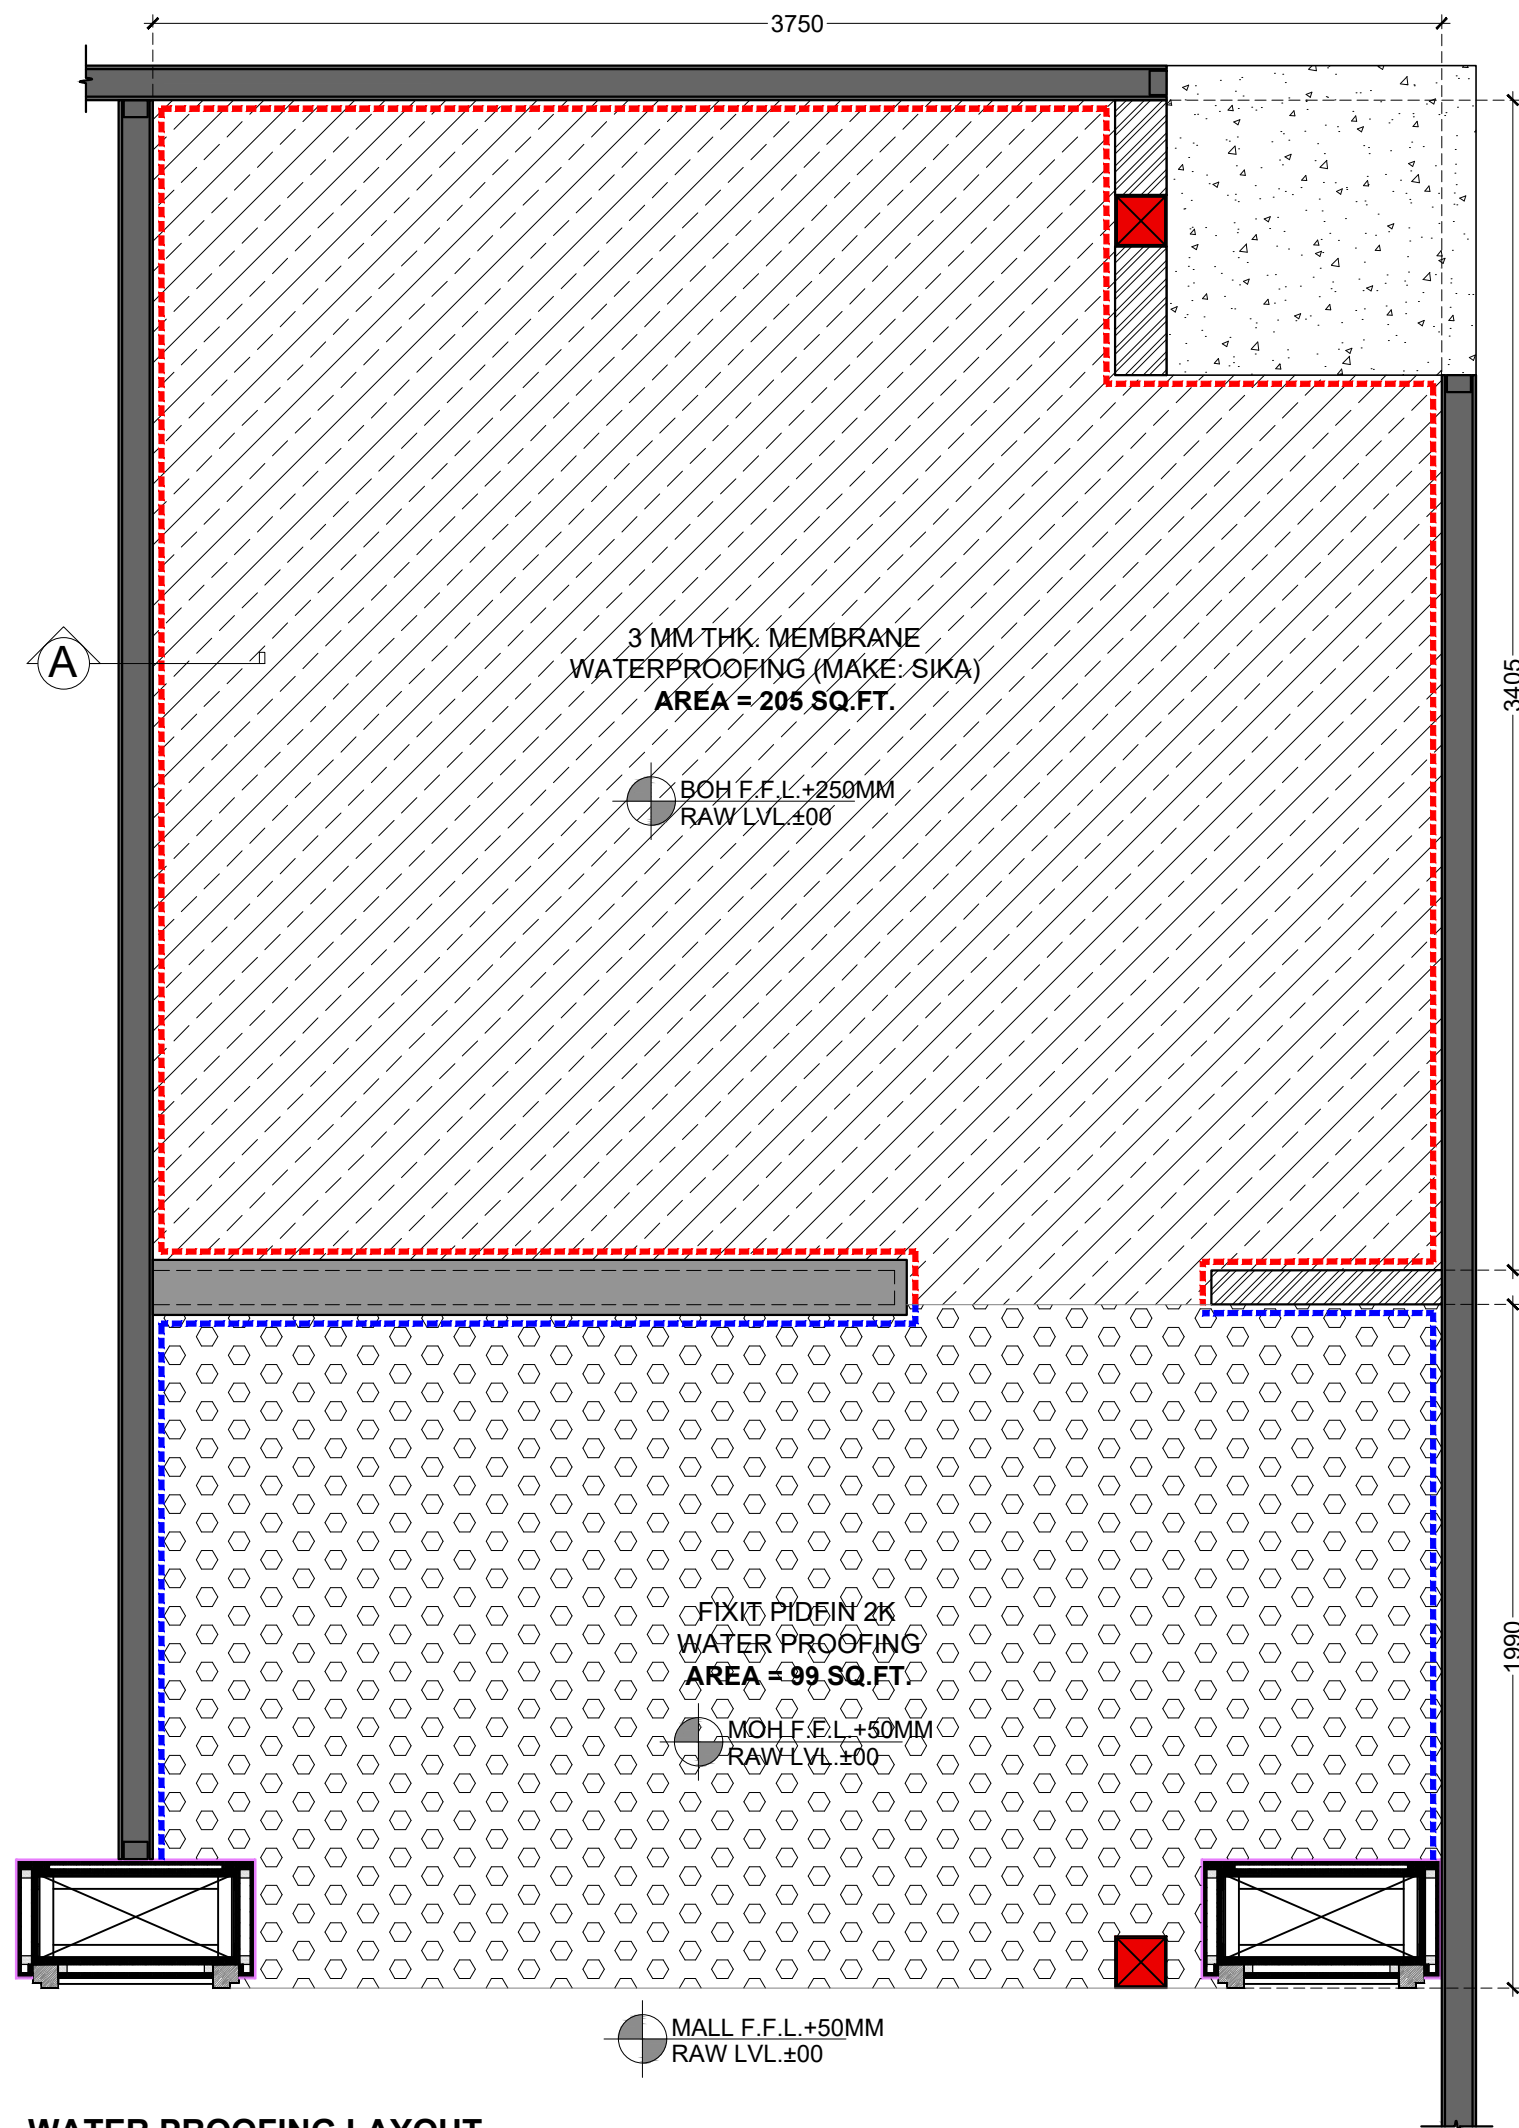

**WATER PROOFING LAYOUT**

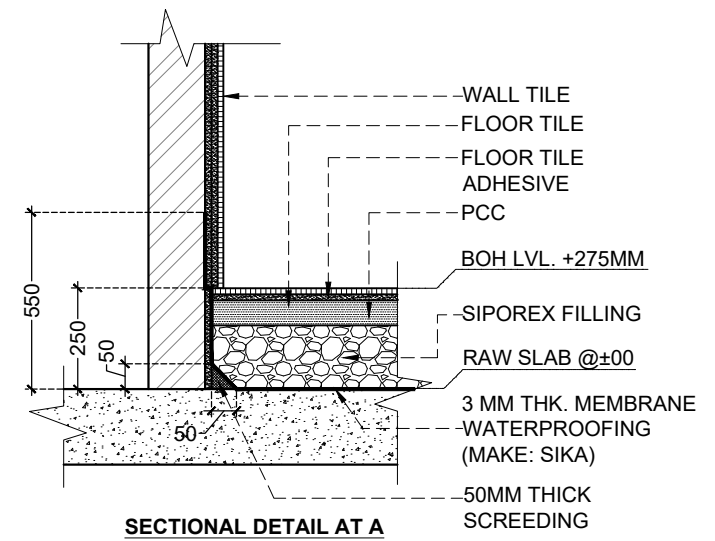

**WATER PROOFING LEGEND**

LEGEND	DESCRIPTION
	3MM THK. MEMBRANE WATER PROOFING AREA (205 SQ.FT.)
	WATER PROOFING ON WALL @ +550MM FROM RAW SLAB.
	DR.FIXIT PIDFIN 2K WATER PROOFING AREA (99 SQ.FT.)
	WATER PROOFING ON WALL @ +350MM FROM RAW SLAB.

**PROJECT**  
 WOW MOMO & WOW CHINA  
 @ AHMEDABAD AIRPORT  
 FOOD COURT, GUJARAT.

**CLIENT**  
 WOW MOMO & WOW CHINA

**NOTE:**  
 THIS DRAWING & DESIGN IS THE COPYRIGHT OF THE DESIGNER. NO PORTION MAY BE REPRODUCED WITHOUT THE WRITTEN PERMISSION OF THE DESIGNERS

1. ALL DIMENSIONS ARE INCLUDING FINISHES
2. DO NOT SCALE DRAWING. ONLY MENTIONED DIMENSIONS ARE TO BE CONSIDERED.
3. ALL DIMENSIONS MUST BE CHECKED BEFORE COMMENCING WORK ON SITE.
4. ANY DISCREPANCIES SHALL BE BROUGHT UNDER THE NOTICE OF ARCHITECTS PRIOR COMMENCEMENT OF WORK.

**REVISION**

S.NO.	REMARKS	DATE
1	REV 1	.....
2	REV 2	
3	REV 3	
4	REV 4	
5	REV 5	
6	REV 6	
7	REV 7	
8	REV 8	

**ARCHITECT / INTERIOR DESIGN**

FLAT NO-13 DDA SFS  
 SLAT POCKET -1 SEC-6 DWARKA,  
 NEW DELHI-110075  
 EMAIL: infoatats@gmail.com  
 OFF-011-35559249, MOB:9910315171

**CONSULTANT**  
 \_\_\_\_\_


**CONSULTANT**  
 \_\_\_\_\_

**RELEASE FOR**

INFORMATION	TENDER	CONSTRUCTION	AS BUILT

**TITLE**  
 WATER PROOFING LAYOUT

DATE	04/10/2023
SCALE	1:25
DRAWN BY	VEDPAL
CHECKED BY	RR.
PRINTED BY	.....
DWG. NO.	IA-104

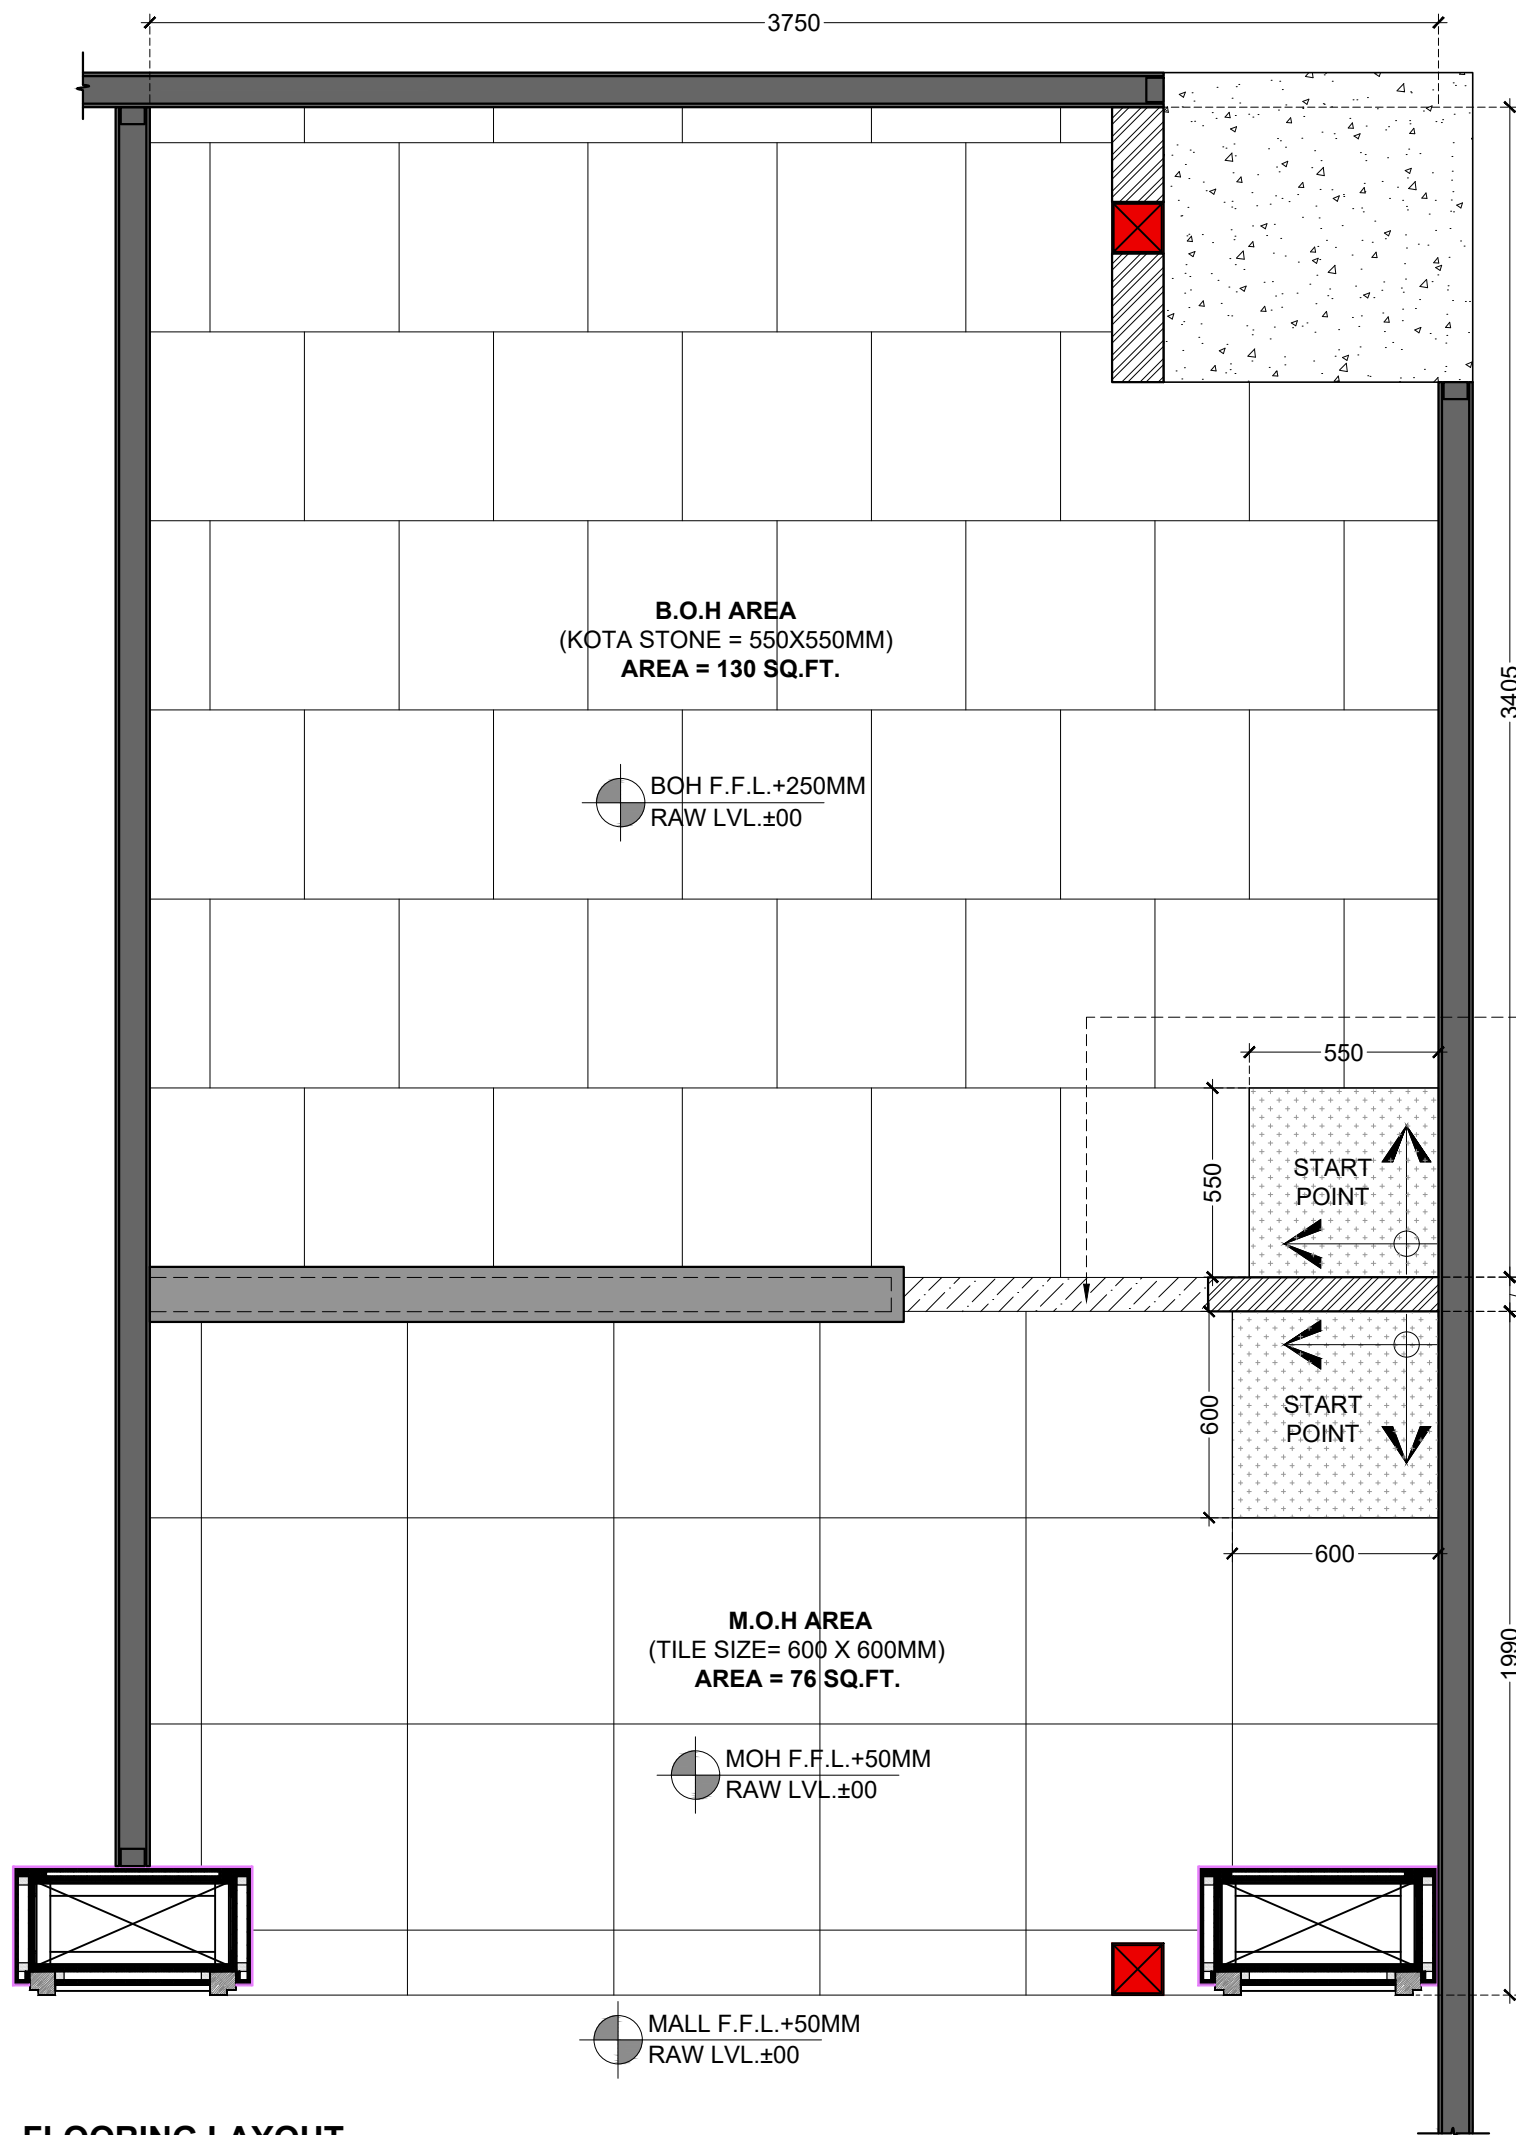

**FLOORING LEGEND**

LEGEND	DESCRIPTION	AREA
	MOH AREA FLOORING 600X600 MM TILE FLOORING & JOINTS TO BE FILLED WITH 3MM LATICRETE EPOXY GROUT	76 SQ.FT
	BOH AREA FLOORING 550X550 MM KOTA STONE FLOORING & JOINTS TO BE FILLED WITH 3MM LATICRETE EPOXY GROUT	130 SQ.FT
	19MM THK. BLACK GRANITE POLISHED	3 SQ.FT
	STARTING POINT	

**OPTION FOR TILES :**

**JOHNSON**

- SANDEX COATED SERIES  
600X600MM 1CM THK. (GREY COATED P)
- SANDEX SALT & PEPPER SERIES  
600X600MM 1M THK. (COLVA P)

**NITCO**

- ULTRA ARGENTO ANTRAITA, 600 X 600MM  
(PREMIUM - FULL BODY, DRY MATTE,  
LAPATO FINISH\*R)
- ONTARIO GIRIS 600 X 600MM  
(PSTONE CREST - FULL BODY,  
MATTE FINISH\*R)

**KAJARIA**

- ALTAS NERO 600 X 600MM
- 6814 ROCK-ANTISKID 600 X 600MM

**PROJECT**  
WOW MOMO & WOW CHINA  
@ AHMEDABAD AIRPORT  
FOOD COURT, GUJARAT.

**CLIENT**  
WOW MOMO & WOW CHINA

**NOTE:**

THIS DRAWING & DESIGN IS THE COPYRIGHT OF THE DESIGNER. NO PORTION MAY BE REPRODUCED WITHOUT THE WRITTEN PERMISSION OF THE DESIGNERS

- ALL DIMENSIONS ARE INCLUDING FINISHES
- DO NOT SCALE DRAWING. ONLY MENTIONED DIMENSIONS ARE TO BE CONSIDERED.
- ALL DIMENSIONS MUST BE CHECKED BEFORE COMMENCING WORK ON SITE.
- ANY DISCREPANCIES SHALL BE BROUGHT UNDER THE NOTICE OF ARCHITECTS PRIOR COMMENCEMENT OF WORK.

**REVISION**

S.NO.	REMARKS	DATE
1	REV 1	
2	REV 2	
3	REV 3	
4	REV 4	
5	REV 5	
6	REV 6	
7	REV 7	
8	REV 8	

**ARCHITECT / INTERIOR DESIGN**

FLAT NO-13 DDA SFS  
SLAT POCKET -1 SEC-6 DWARKA,  
NEW DELHI-110075  
EMAIL:-info@osstudio.com  
OFF-011-35559249, MOB-9910315171

**CONSULTANT**

\_\_\_\_\_

**CONSULTANT**

\_\_\_\_\_


**RELEASE FOR**

INFORMATION	TENDER	CONSTRUCTION	AS BUILT

**TITLE**  
FLOORING LAYOUT

DATE	04/10/2023
SCALE	1:25
DRAWN BY	VEDPAL
CHECKED BY	RR.
PRINTED BY	_____
DWG. NO.	IA-105

**FLOORING LAYOUT**

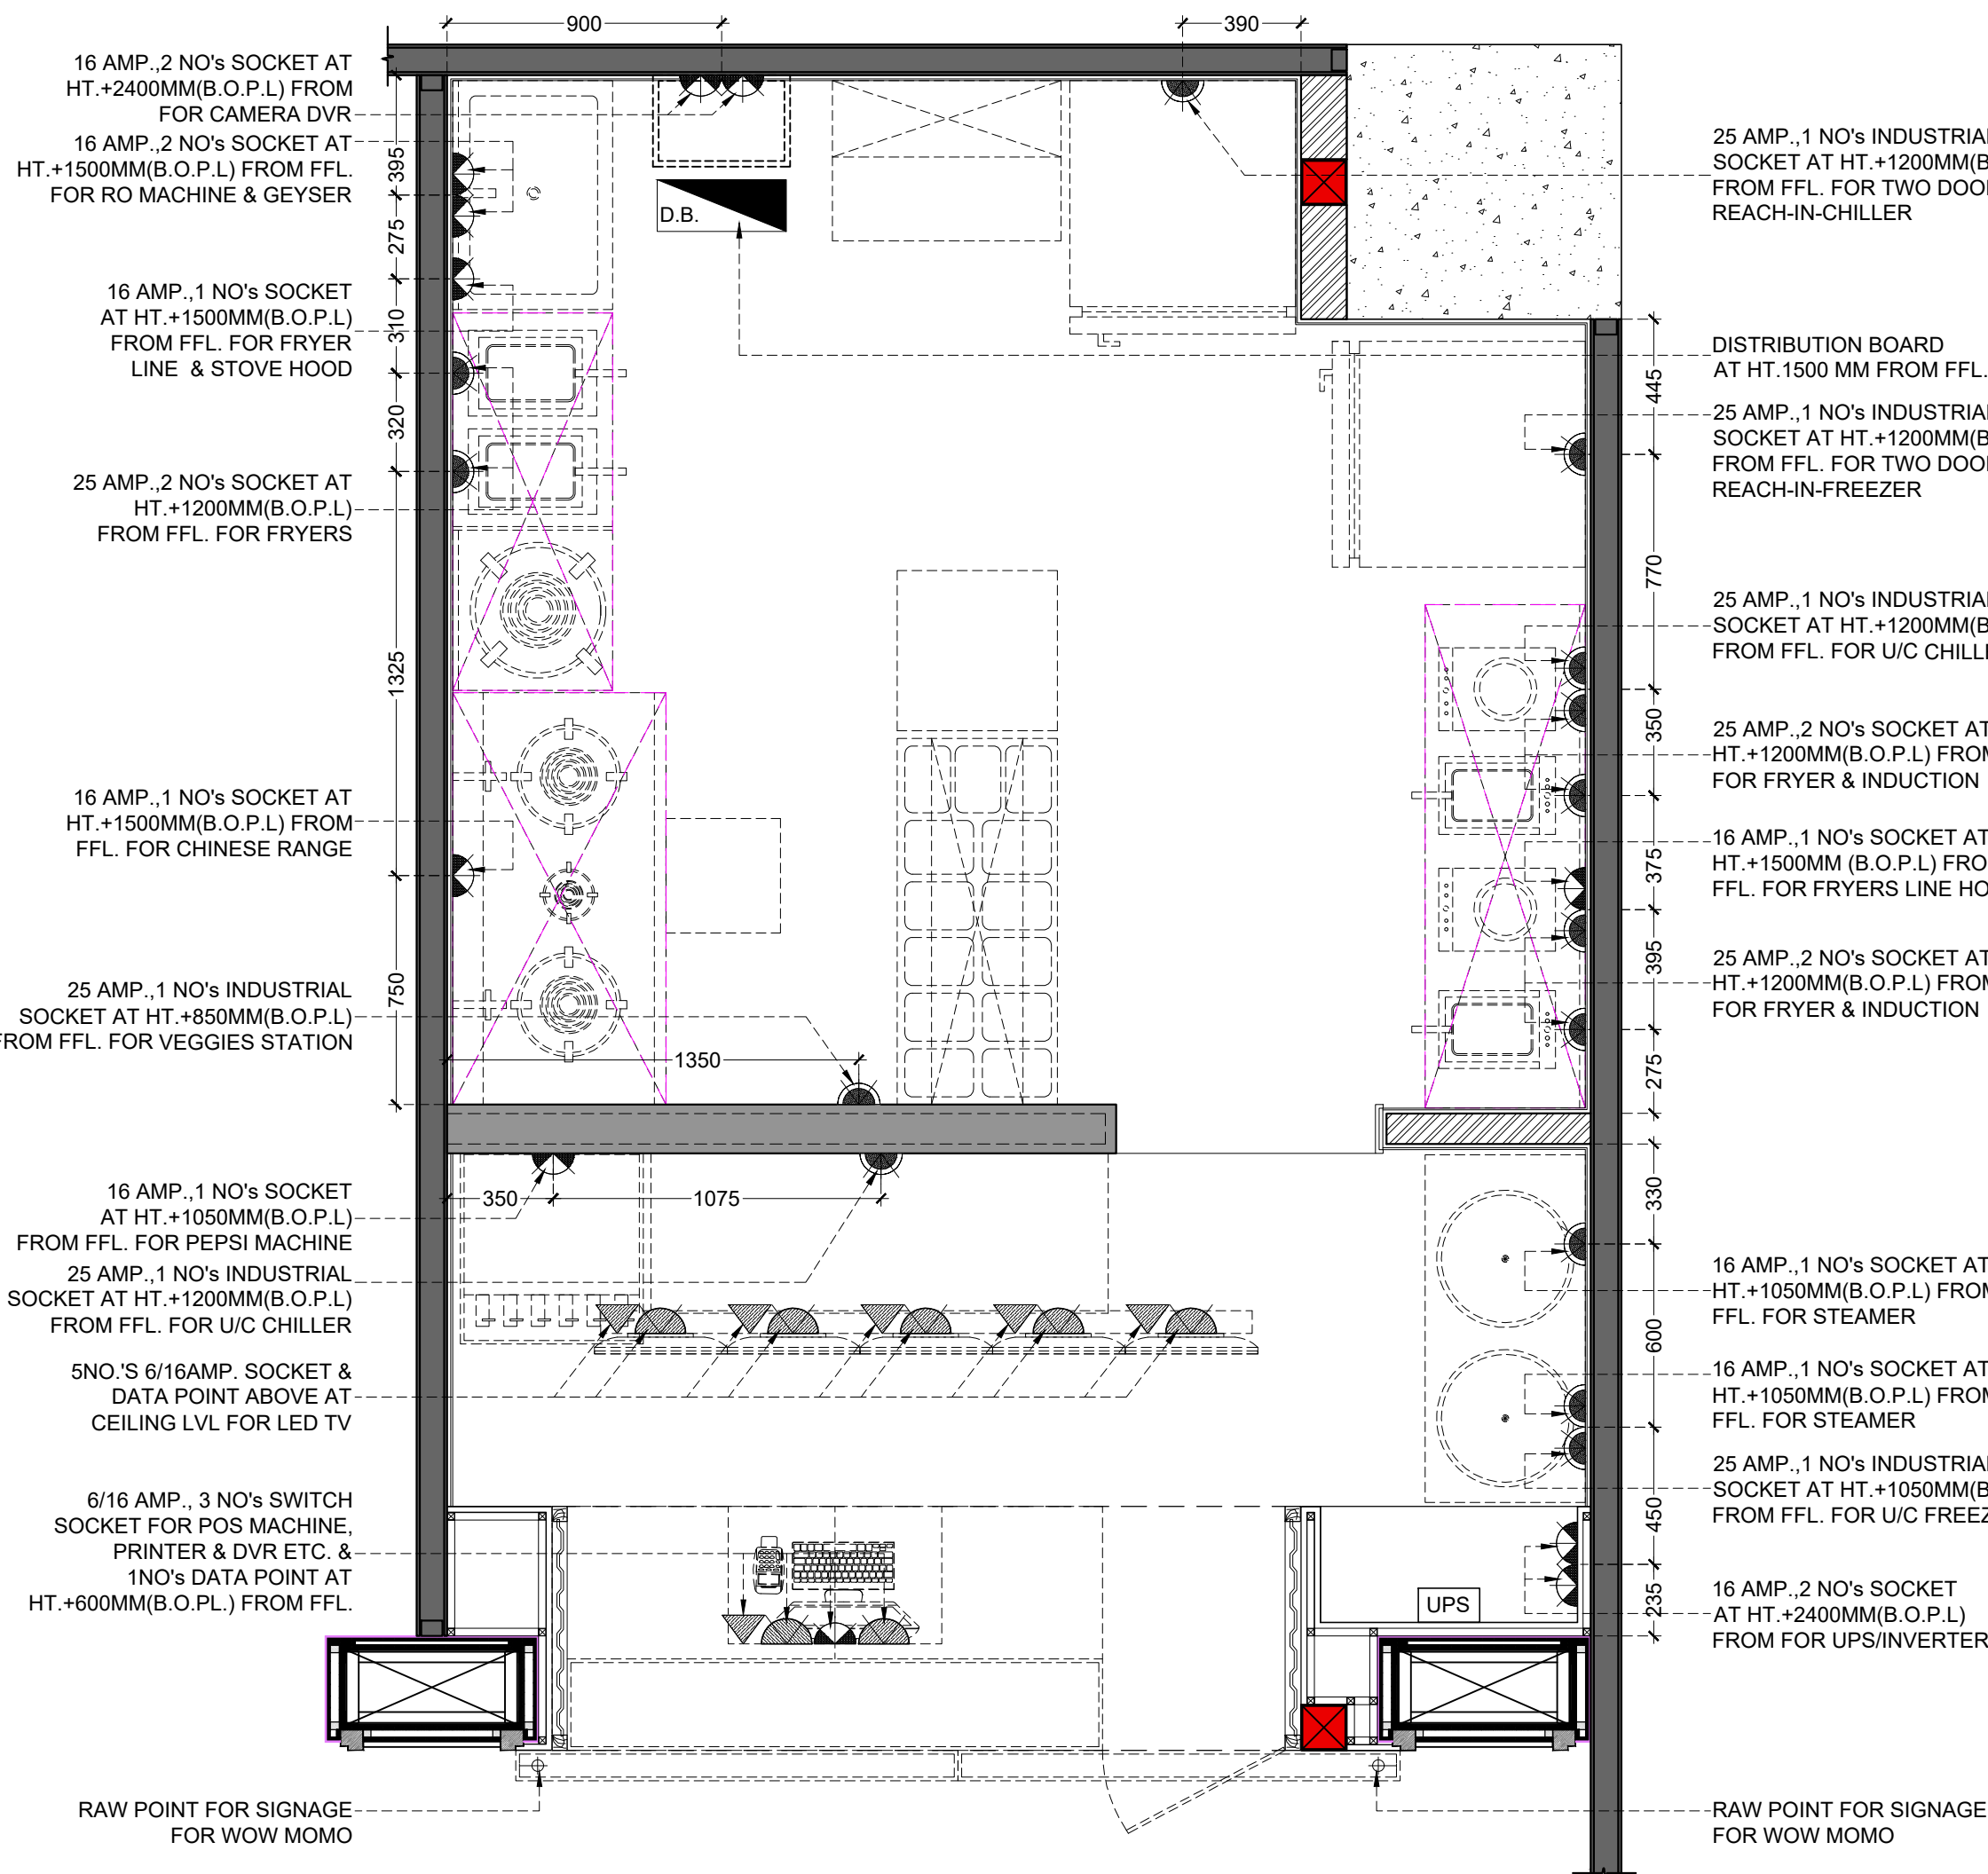

**WALL ELECTRICAL LAYOUT**

**PROJECT**

WOW MOMO & WOW CHINA  
@ AHMEDABAD AIRPORT  
FOOD COURT, GUJARAT.

**CLIENT**

WOW MOMO & WOW CHINA

**NOTE:**

THIS DRAWING & DESIGN IS THE COPYRIGHT OF THE DESIGNER. NO PORTION MAY BE REPRODUCED WITHOUT THE WRITTEN PERMISSION OF THE DESIGNERS

1. ALL DIMENSIONS ARE INCLUDING FINISHES
2. DO NOT SCALE DRAWING. ONLY MENTIONED DIMENSIONS ARE TO BE CONSIDERED.
3. ALL DIMENSIONS MUST BE CHECKED BEFORE COMMENCING WORK ON SITE.
4. ANY DISCREPANCIES SHALL BE BROUGHT UNDER THE NOTICE OF ARCHITECTS PRIOR COMMENCEMENT OF WORK.

**REVISION**

S.NO.	REMARKS	DATE
1	REV 1	.....
2	REV 2	
3	REV 3	
4	REV 4	
5	REV 5	
6	REV 6	
7	REV 7	
8	REV 8	

**ARCHITECT / INTERIOR DESIGN**



FLAT NO-13 DDA SFS  
SLAT POCKET -1 SEC-6 DWARKA,  
NEW DELHI-110075  
EMAIL: infoatats@gmail.com  
OFF-011-35559249, MOB-9910315171

**CONSULTANT**

.....

**CONSULTANT**

.....

**RELEASE FOR**

INFORMATION | TENDER | CONSTRUCTION | AS BUILT

.....

**TITLE**

WALL ELECTRICAL LAYOUT


DATE	03/11/2023
SCALE	1:25
DRAWN BY	VEDPAL
CHECKED BY	RR.
PRINTED BY	.....
DWG. NO.	IA-106

**ELECTRICAL LEGEND**

1. 25 AMP INDUSTRIAL SOCKET
2. 16 AMP SOCKET
3. 6 AMP SOCKET
4. DB(MCB)
5. ELECTRICAL POINT

**NOTE-**  
1. USE ONLY G.I. CONDUITS FOR WIRING.  
2. STANDARD D.B. WITH NEUTRAL LINK ON EACH PHASE TO BE USED.  
3. UPS CONNECTION AND PROVISION TO EMERGENCY LIGHTS, POS AND SIGNAGE SHOULD BE DONE.  
4. ALL B.O.PL ARE FROM FLOOR FINISH LEVEL



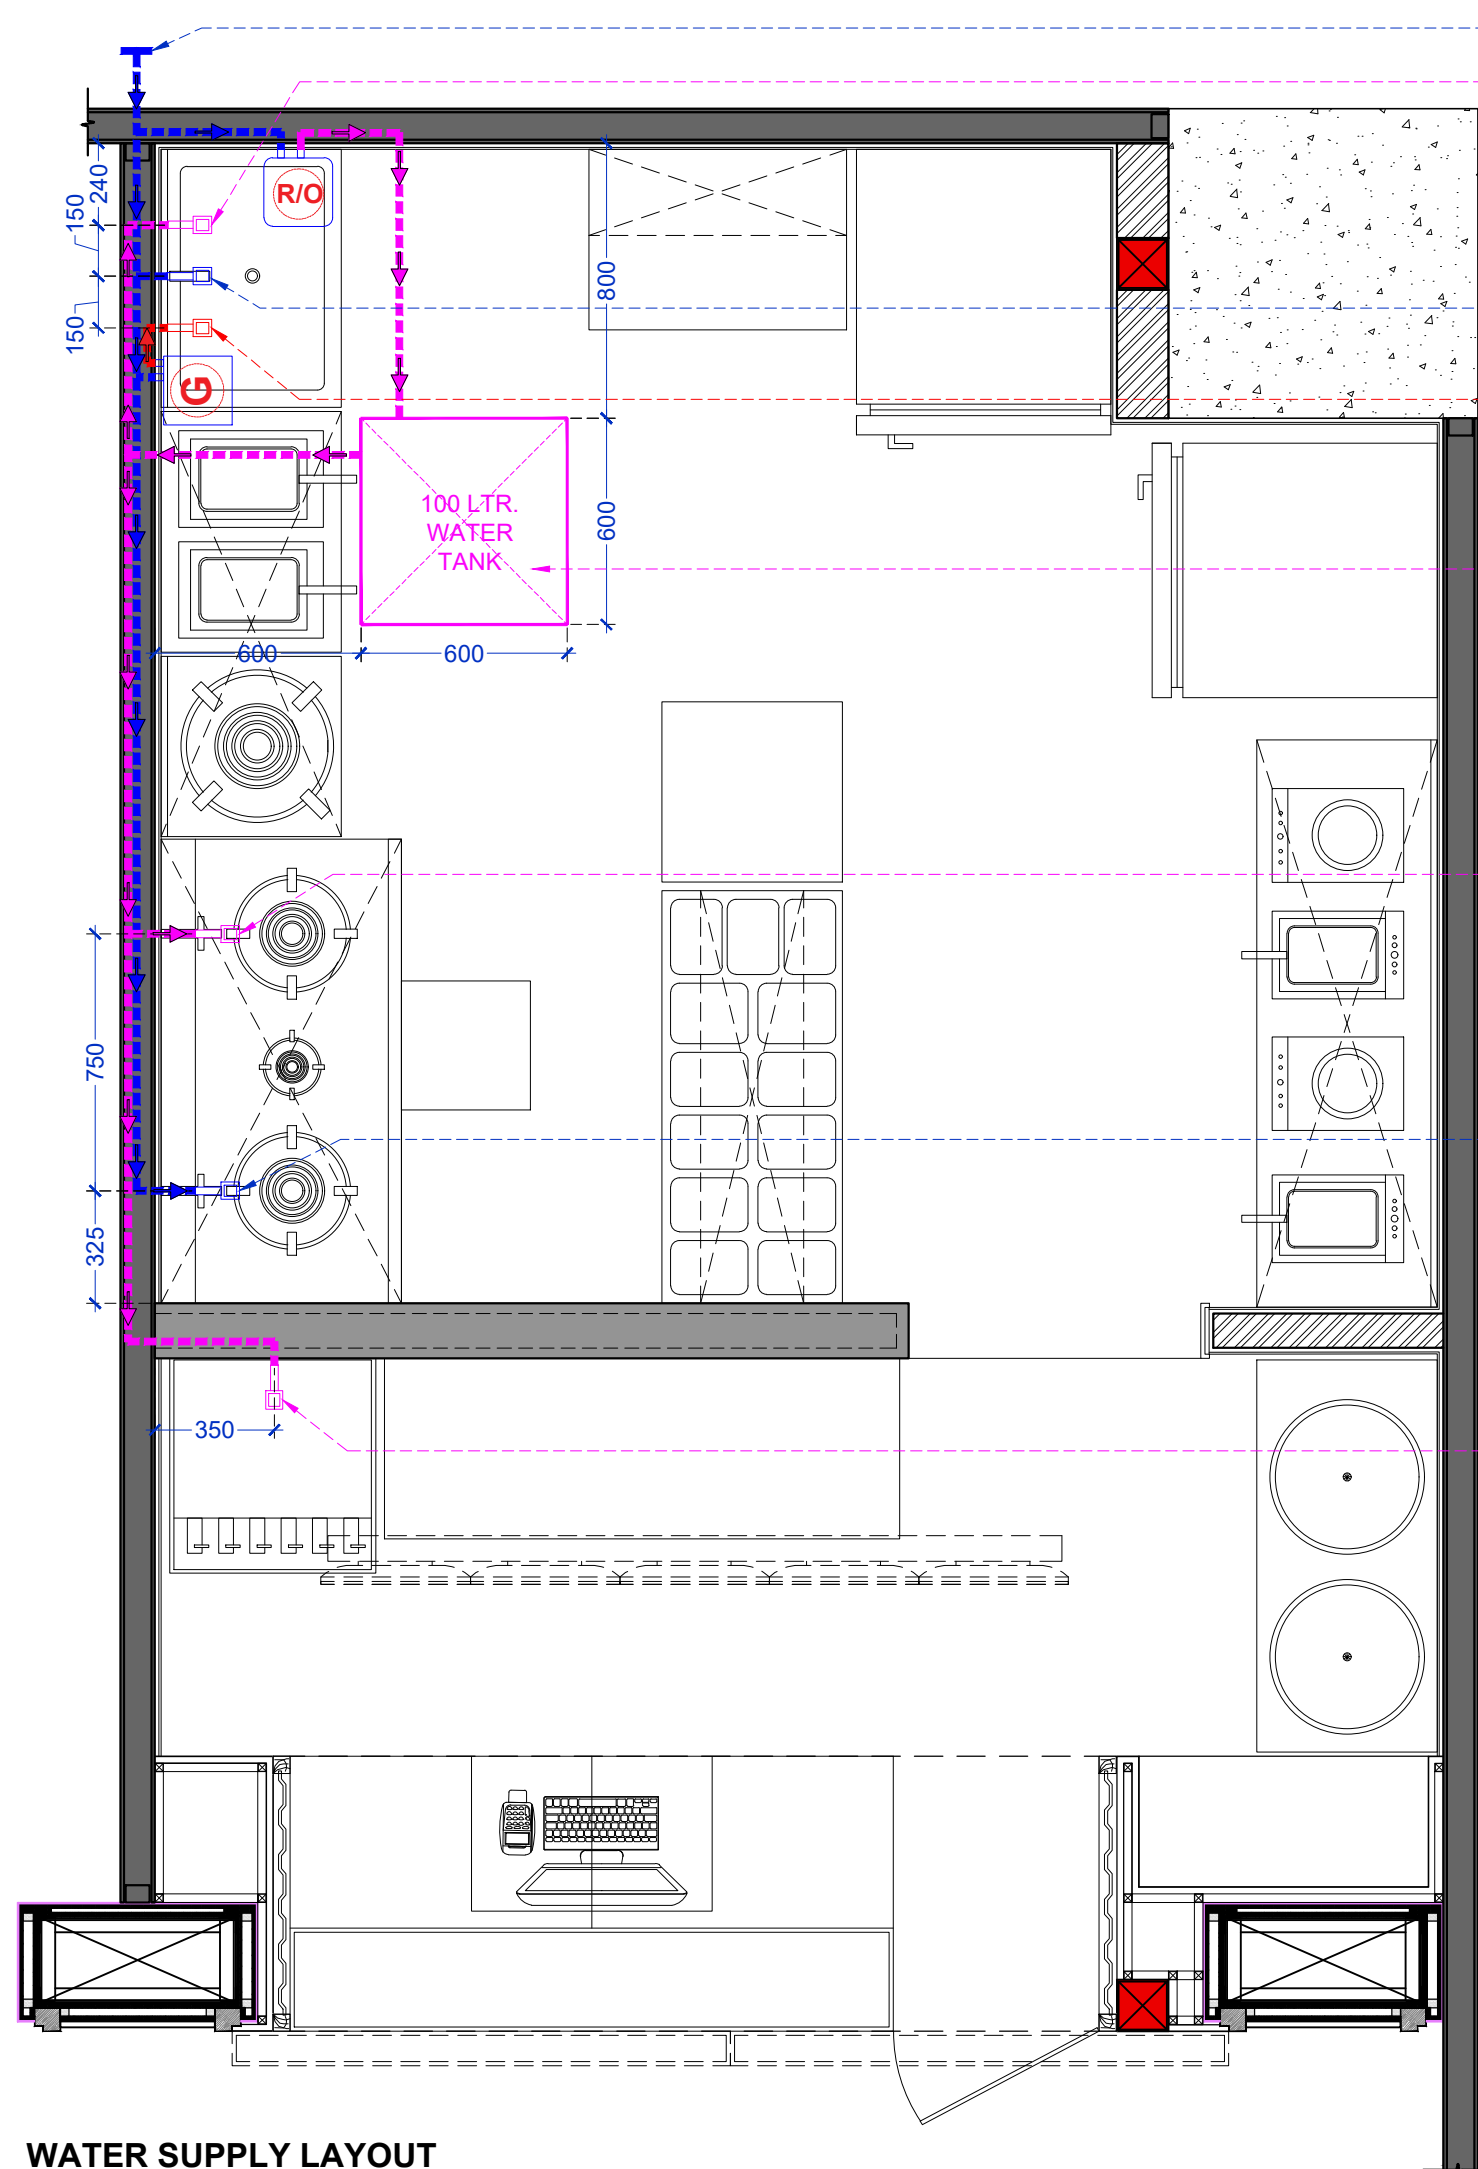

CONNECT WITH EXISTING DWS PIPE  
 20MM Ø RO WS@+450MM HT. F.F.L. FOR ANGLE VALVE & FOR TAP +1050MM HT.

20MM Ø DWS @+450MM HT. F.F.L. FOR ANGLE VALVE & FOR TAP +1050MM HT.

20MM Ø HWS @+450MM HT. F.F.L. FOR ANGLE VALVE & FOR TAP +1050MM HT.

100 LTR. RO WATER TANK FIXED AT CEILING MOUNTED

20MM Ø RO WS@+450MM HT. F.F.L. FOR ANGLE VALVE & FOR TAP +1050MM HT.

20MM Ø DWS @+450MM HT. F.F.L. FOR ANGLE VALVE & FOR TAP +1050MM HT.

20MM Ø R/O WS @+450MM HT. FROM FFL. FOR PEPSI MACHINE AT ANGLE VALVE & FOR TAP HT. AS/SITE.

WATER SUPPLY LEGEND	
S.NO.	DESCRIPTION
---	DOMESTIC WATER SUPPLY
---	HOT WATER SUPPLY
---	RO WATER SUPPLY
	R.O. SYSTEM
	GEYSER
	100 LTR. R.O. WATER TANK

**PROJECT**  
 WOW MOMO & WOW CHINA  
 @ AHMEDABAD AIRPORT  
 FOOD COURT, GUJARAT.

**CLIENT**  
 WOW MOMO & WOW CHINA

**NOTE:**  
 THIS DRAWING & DESIGN IS THE COPYRIGHT OF THE DESIGNER. NO PORTION MAY BE REPRODUCED WITHOUT THE WRITTEN PERMISSION OF THE DESIGNERS

1. ALL DIMENSIONS ARE INCLUDING FINISHES
2. DO NOT SCALE DRAWING. ONLY MENTIONED DIMENSIONS ARE TO BE CONSIDERED.
3. ALL DIMENSIONS MUST BE CHECKED BEFORE COMMENCING WORK ON SITE.
4. ANY DISCREPANCIES SHALL BE BROUGHT UNDER THE NOTICE OF ARCHITECTS PRIOR COMMENCEMENT OF WORK.

**REVISION**

S.NO.	REMARKS	DATE
1	REV 1	
2	REV 2	
3	REV 3	
4	REV 4	
5	REV 5	
6	REV 6	
7	REV 7	
8	REV 8	

**ARCHITECT / INTERIOR DESIGN**

FLAT NO-13 DDA SFS  
 SLAT POCKET -1 SEC-6 DWARKA,  
 NEW DELHI-110075  
 EMAIL: info@osstudio.com  
 OFF-011-35559249, MOB-9910315171

**CONSULTANT**  
 \_\_\_\_\_

**CONSULTANT**  
 \_\_\_\_\_


**RELEASE FOR**

INFORMATION	TENDER	CONSTRUCTION	AS BUILT

**TITLE**  
 WATER SUPPLY LAYOUT

DATE	03/11/2023
SCALE	1:25
DRAWN BY	VEDPAL
CHECKED BY	RR.
PRINTED BY	-----
DWG. NO.	IA-107

**WATER SUPPLY LAYOUT**

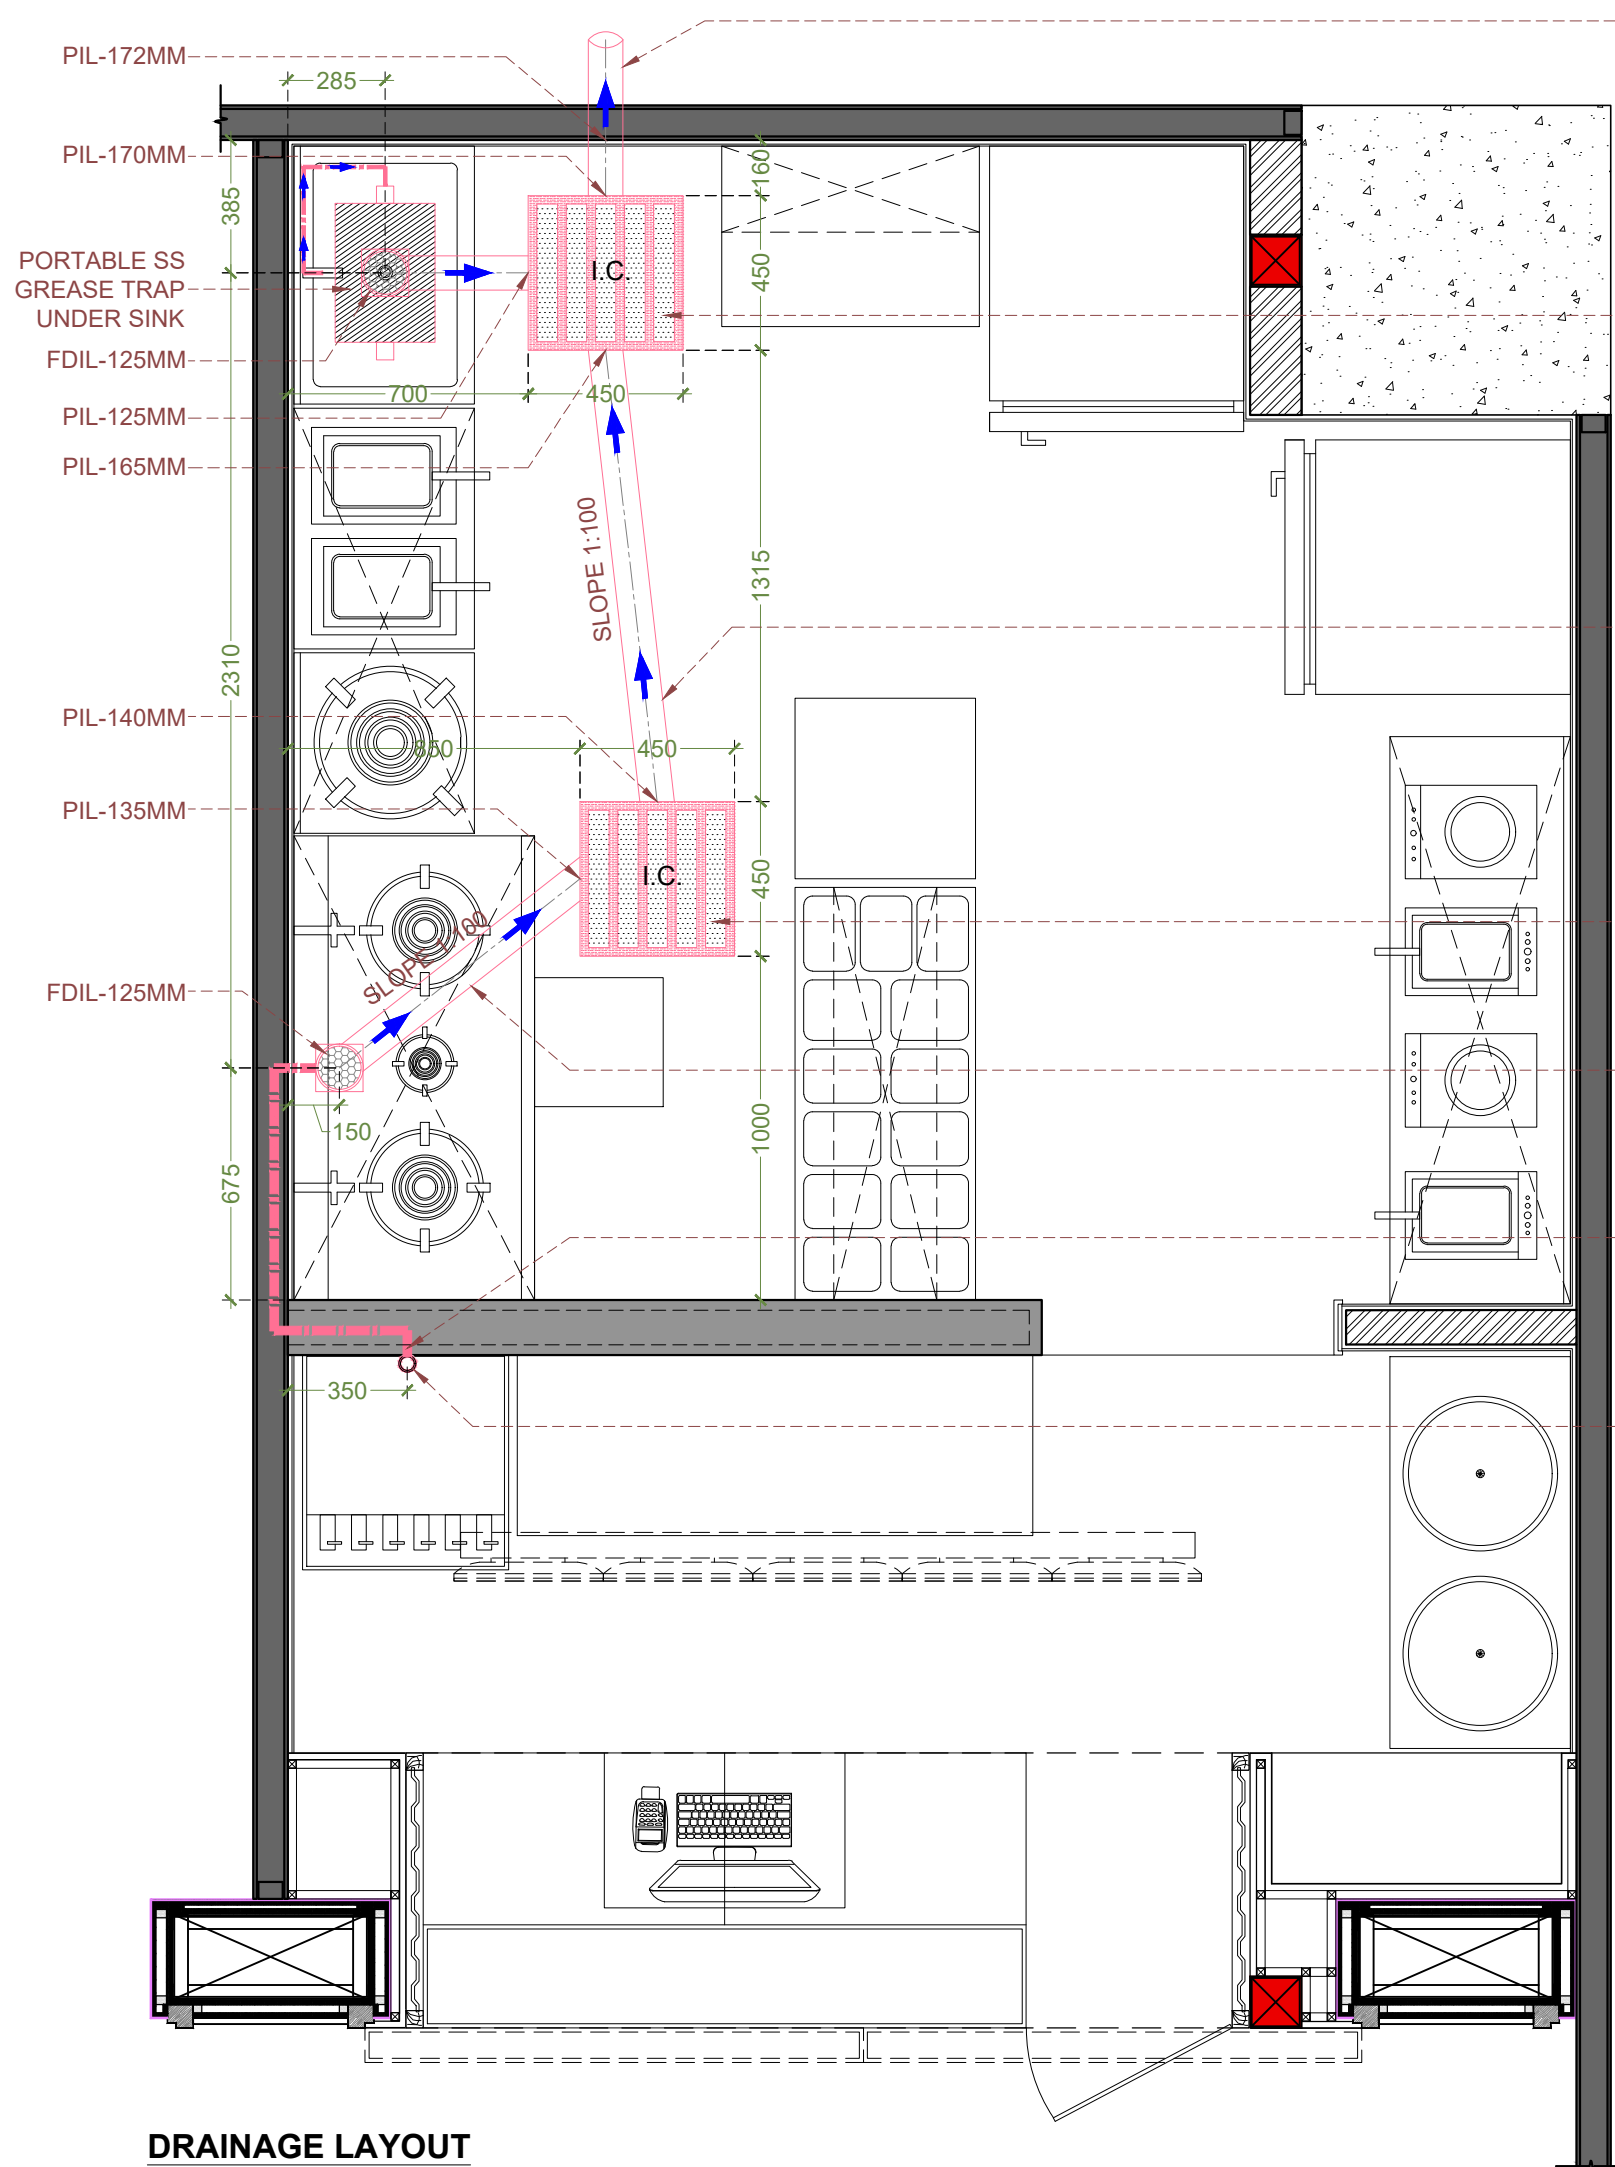

100MM Ø WASTE WATER PIPE CONNECTED TO EXISTING MALL DRAIN

INSPECTION CHAMBER (I.C.) 450X450 MM

100MM Ø PVC PIPE

INSPECTION CHAMBER (I.C.) 450X450 MM

100MM Ø PVC PIPE

50MM Ø CONCEALED PIPE

BOTTLE TRAP FOR PEPSI MACHINE

DRAINAGE LEGEND	
S.NO.	DESCRIPTION
---	100MM Ø UPVC PIPE
	50MM DIA CONCEALED PIPE
I.C.	INSPECTION CHAMBER (I.C.) 450X450MM
⊙	FLOOR TRAP
▨	PORTABLE GREASE TRAP

NOTE: ALL PIPE SLOPE IS 1:100

**PROJECT**  
 WOW MOMO & WOW CHINA  
 @ AHMEDABAD AIRPORT  
 FOOD COURT, GUJARAT.

**CLIENT**  
 WOW MOMO & WOW CHINA

**NOTE:**  
 THIS DRAWING & DESIGN IS THE COPYRIGHT OF THE DESIGNER. NO PORTION MAY BE REPRODUCED WITHOUT THE WRITTEN PERMISSION OF THE DESIGNERS

1. ALL DIMENSIONS ARE INCLUDING FINISHES
2. DO NOT SCALE DRAWING. ONLY MENTIONED DIMENSIONS ARE TO BE CONSIDERED.
3. ALL DIMENSIONS MUST BE CHECKED BEFORE COMMENCING WORK ON SITE.
4. ANY DISCREPANCIES SHALL BE BROUGHT UNDER THE NOTICE OF ARCHITECTS PRIOR COMMENCEMENT OF WORK.

**REVISION**

S.NO.	REMARKS	DATE
1	REV 1	.....
2	REV 2	
3	REV 3	
4	REV 4	
5	REV 5	
6	REV 6	
7	REV 7	
8	REV 8	

**ARCHITECT / INTERIOR DESIGN**

FLAT NO-13 DDA SFS  
 SLAT POCKET -1 SEC-6 DWARKA,  
 NEW DELHI-110075  
 EMAIL: infoatats@gmail.com  
 OFF-011-35559249, MOB:9910315171

**CONSULTANT**  
 \_\_\_\_\_

**CONSULTANT**  
 \_\_\_\_\_

**RELEASE FOR**

INFORMATION	TENDER	CONSTRUCTION	AS BUILT

**TITLE**  
 DRAINAGE LAYOUT

DATE	04/10/2023
SCALE	1:25
DRAWN BY	VEDPAL
CHECKED BY	RR.
PRINTED BY	-----
DWG. NO.	IA-108

**DRAINAGE LAYOUT**

**PROJECT**

WOW MOMO & WOW CHINA  
@ AHMEDABAD AIRPORT  
FOOD COURT, GUJARAT.

**CLIENT**  
WOW MOMO & WOW CHINA

**NOTE:**

THIS DRAWING & DESIGN IS THE COPYRIGHT OF THE DESIGNER. NO PORTION MAY BE REPRODUCED WITHOUT THE WRITTEN PERMISSION OF THE DESIGNERS

1. ALL DIMENSIONS ARE INCLUDING FINISHES
2. DO NOT SCALE DRAWING. ONLY MENTIONED DIMENSIONS ARE TO BE CONSIDERED.
3. ALL DIMENSIONS MUST BE CHECKED BEFORE COMMENCING WORK ON SITE.
4. ANY DISCREPANCIES SHALL BE BROUGHT UNDER THE NOTICE OF ARCHITECTS PRIOR COMMENCEMENT OF WORK.

**REVISION**

S.NO.	REMARKS	DATE
1	REV 1	.....
2	REV 2	
3	REV 3	
4	REV 4	
5	REV 5	
6	REV 6	
7	REV 7	
8	REV 8	

**ARCHITECT / INTERIOR DESIGN**



**CONSULTANT**

**CONSULTANT**

**RELEASE FOR**

INFORMATION	TENDER	CONSTRUCTION	AS BUILT
-------------	--------	--------------	----------


**TITLE**

REFLECTED CEILING PLAN

DATE	04/10/2023
SCALE	1:25
DRAWN BY	VEDPAL
CHECKED BY	RR.
PRINTED BY	.....
DWG. NO.	IA-109

**LIGHTING LEGEND**

S.NO.	DESCRIPTION	QTY.
⊗	150MM Ø SURFACE LIGHT	23
⊗	300 MM Ø HANGING LIGHT	04
EL	EMEGENCY LIGHT	

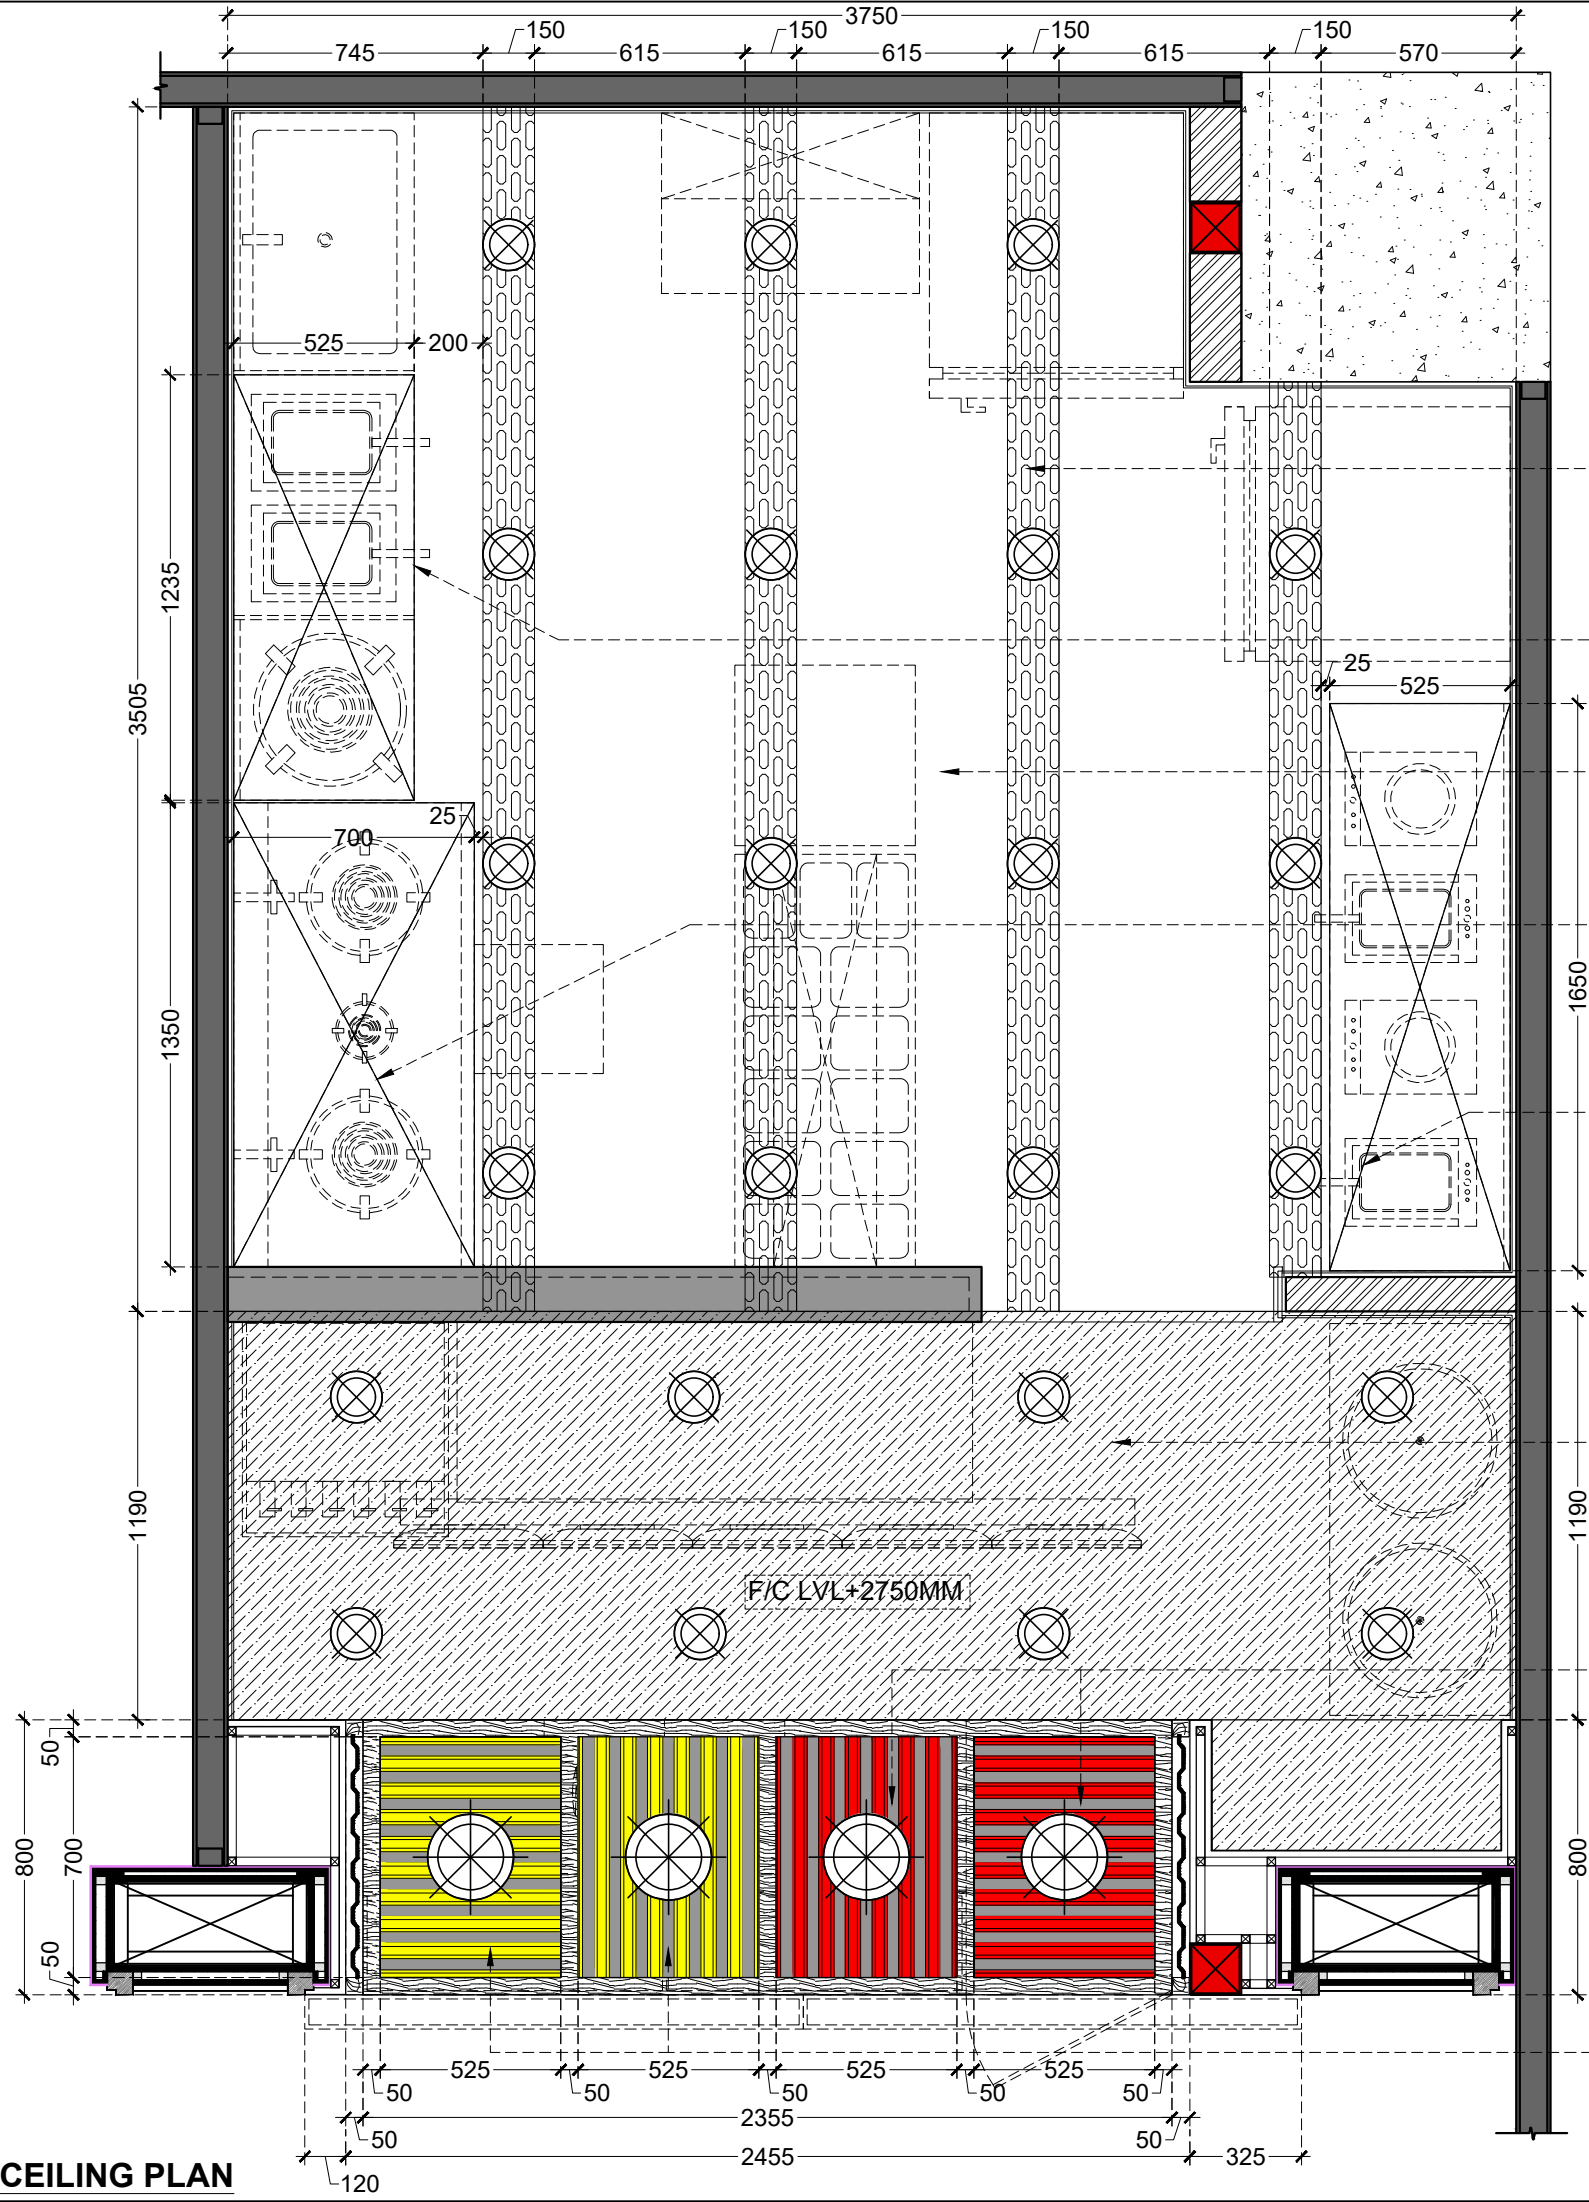

150MM WIDE CABLE TRAY  
FINISHED WITH OBSIDIAN GLASS  
00NN 13/000 PAINT (MAKE-  
DULUX) BOTTOM OF  
LVL.+2600 MM. FROM FFL.

SS HOOD ABOVE FRYING  
LINE & STOVE AS/APP.  
(SIZE= 1235X525 MM)

BOTTOM OF SLAB & BEAM  
FINISHED WITH OBSIDIAN  
GLASS 00NN 13/000 PAINT  
(MAKE- DULUX) OVER  
POP OR PUTTY BASE

SS HOOD ABOVE CHINESE  
RANGE AS/APP.  
(SIZE= 1350X700 MM)

SS HOOD ABOVE FRYING  
LINE AS/APP.  
(SIZE= 1650X525 MM)

PERLINA TEXTURE PAINT  
OVER GYPSUM BOARD CEILING,  
HT.+2750 MM. FROM FFL.

25X25MM MS TUBE FRAMEWORK  
FINISHED WITH 19MM THK. PLY  
ABOVE THAT 50X50MM OAK WOOD  
FRAMEWORK FINISHED WITH  
NATURAL MATT POLISH & IN  
BETWEEN FRAMEWORK  
CORRUGATED SHEET TO BE FIXED  
PAINTED IN RED & GREY COLOUR  
AT HT.+2325 MM FROM FFL.

25X25MM MS TUBE FRAMEWORK  
FINISHED WITH 19MM THK. PLY  
ABOVE THAT 50X50MM OAK WOOD  
FRAMEWORK FINISHED WITH  
NATURAL MATT POLISH & IN  
BETWEEN FRAMEWORK  
CORRUGATED SHEET TO BE FIXED  
PAINTED IN YELLOW & GREY  
COLOUR AT HT.+2325 MM FROM FFL.

**REFLECTED CEILING PLAN**

**PROJECT**

WOW MOMO & WOW CHINA  
@ AHMEDABAD AIRPORT  
FOOD COURT, GUJARAT.

**CLIENT**  
WOW MOMO & WOW CHINA

**NOTE:**

THIS DRAWING & DESIGN IS THE COPYRIGHT OF THE DESIGNER. NO PORTION MAY BE REPRODUCED WITHOUT THE WRITTEN PERMISSION OF THE DESIGNERS

1. ALL DIMENSIONS ARE INCLUDING FINISHES
2. DO NOT SCALE DRAWING. ONLY MENTIONED DIMENSIONS ARE TO BE CONSIDERED.
3. ALL DIMENSIONS MUST BE CHECKED BEFORE COMMENCING WORK ON SITE.
4. ANY DISCREPANCIES SHALL BE BROUGHT UNDER THE NOTICE OF ARCHITECTS PRIOR COMMENCEMENT OF WORK.

**REVISION**

S.NO.	REMARKS	DATE
1	REV 1	
2	REV 2	
3	REV 3	
4	REV 4	
5	REV 5	
6	REV 6	
7	REV 7	
8	REV 8	

**ARCHITECT / INTERIOR DESIGN**



FLAT NO-13 DDA SFS  
SLAT POCKET -1 SEC-6 DWARKA,  
NEW DELHI-110075  
EMAIL: infoatats@gmail.com  
OFF-011-35559249, MOB:9910315171

**CONSULTANT**

**CONSULTANT**

**RELEASE FOR**

INFORMATION | TENDER | CONSTRUCTION | AS BUILT


**TITLE**

LIGHTING LAYOUT

DATE	04/10/2023
SCALE	1:25
DRAWN BY	VEDPAL
CHECKED BY	RR.
PRINTED BY	-----
DWG. NO.	IA-110

**LIGHTING LEGEND**

S.NO.	DESCRIPTION	QTY.
⊗	150MM Ø SURFACE LIGHT	23
⊗ (with vertical lines)	300 MM Ø HANGING LIGHT	04
EL	EMEGENCY LIGHT	

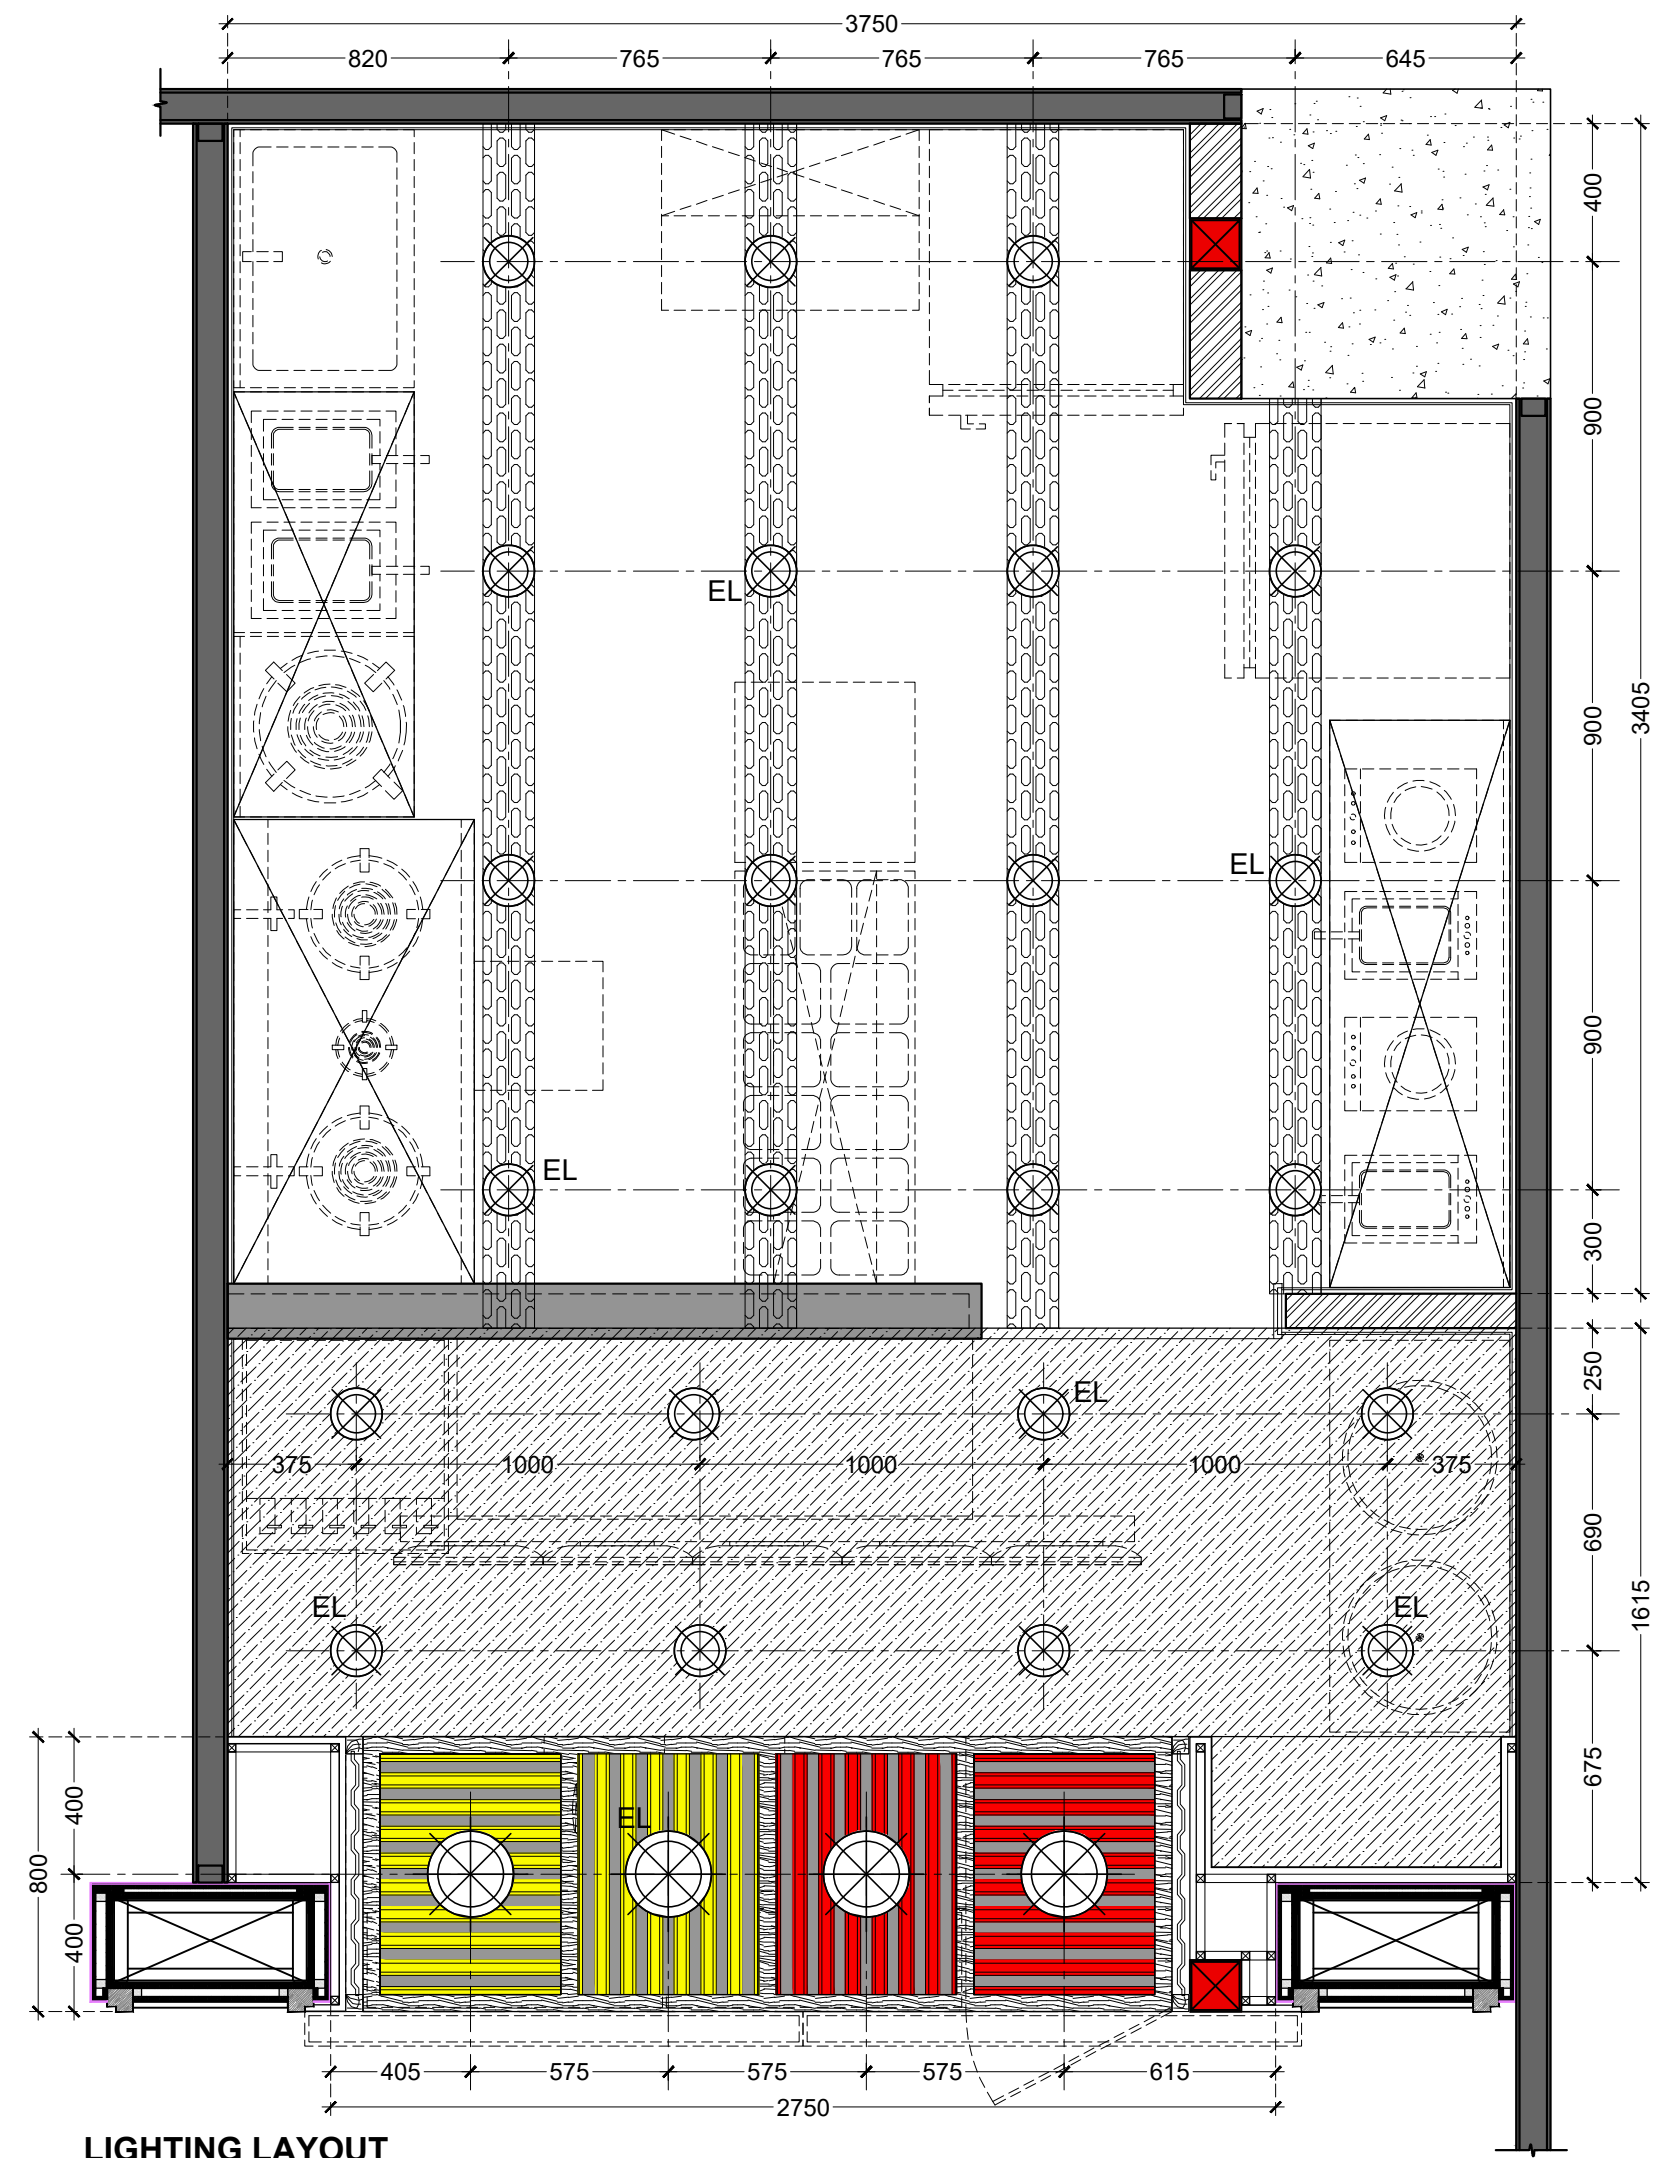

**LIGHTING LAYOUT**

3715

PROJECT

WOW MOMO & WOW CHINA @ AHMEDABAD AIRPORT FOOD COURT, GUJARAT.

CLIENT  
WOW MOMO & WOW CHINA

NOTE:  
THIS DRAWING & DESIGN IS THE COPYRIGHT OF THE DESIGNER. NO PORTION MAY BE REPRODUCED WITHOUT THE WRITTEN PERMISSION OF THE DESIGNERS

1. ALL DIMENSIONS ARE INCLUDING FINISHES
2. DO NOT SCALE DRAWING. ONLY MENTIONED DIMENSIONS ARE TO BE CONSIDERED.
3. ALL DIMENSIONS MUST BE CHECKED BEFORE COMMENCING WORK ON SITE.
4. ANY DISCREPANCIES SHALL BE BROUGHT UNDER THE NOTICE OF ARCHITECTS PRIOR COMMENCEMENT OF WORK.

REVISION

S.NO.	REMARKS	DATE
1	REV 1	
2	REV 2	
3	REV 3	
4	REV 4	
5	REV 5	
6	REV 6	
7	REV 7	
8	REV 8	

ARCHITECT / INTERIOR DESIGN



CONSULTANT

CONSULTANT

RELEASE FOR

INFORMATION	TENDER	CONSTRUCTION	AS BUILT
-------------	--------	--------------	----------

TITLE

WALL FINISHES LAYOUT

DATE 04/10/2023

SCALE 1:25

DRAWN BY VEDPAL

CHECKED BY RR.

PRINTED BY

DWG. NO. IA-111

200X100MM HI.GLOSS BLACK SUBWAY WALL TILE (MAKE: JOHNSON) FINISH UPTO +2400MM FROM FFL. & ABOVE 2400MM TILL BOS. OBSIDIAN GLASS 00NN 13/000 (MAKE-DULUX) PAINT FINISH OVER POP PUNNING WALL.

200X100MM HI.GLOSS BLACK SUBWAY WALL TILE (MAKE: JOHNSON) FINISH UPTO +2400MM FROM FFL. & ABOVE 2400MM TILL BOS. OBSIDIAN GLASS 00NN 13/000 (MAKE-DULUX) PAINT FINISH OVER POP PUNNING WALL.

200X100MM HI.GLOSS BLACK SUBWAY WALL TILE (MAKE: JOHNSON) FINISH UPTO +2400MM FROM FFL. & ABOVE 2400MM TILL BOS. OBSIDIAN GLASS 00NN 13/000 (MAKE-DULUX) PAINT FINISH OVER POP PUNNING WALL.

12MM THK. GREY CORIAN

200X100MM HI.GLOSS BLACK SUBWAY WALL TILE (MAKE: JOHNSON) FINISH UPTO BOTTOM OF CORIAN TOP

200X100MM HI.GLOSS BLACK SUBWAY WALL TILE (MAKE: JOHNSON) FINISH UPTO +2400MM FROM FFL. & ABOVE 2400MM TILL BOS. OBSIDIAN GLASS 00NN 13/000 (MAKE-DULUX) PAINT FINISH OVER POP PUNNING WALL.

200X100MM HI.GLOSS RED(60%), BLACK(20%), GREY(20%) SUBWAY WALL TILE(MAKE: JOHNSON) +1200MM FROM FFL. 25X25MM THK OAK WOOD BEADING AND ABOVE PERLINA TEXTURE PAINT FIN. OVER POP PUNNING WALL(AS/SECTIONAL ELEVATION)

200X100MM HI.GLOSS RED(60%), BLACK(20%), GREY(20%) SUBWAY WALL TILE(MAKE: JOHNSON) +1200MM FROM FFL. 25X25MM THK OAK WOOD BEADING AND ABOVE PERLINA TEXTURE PAINT FIN. OVER POP PUNNING WALL(AS/SECTIONAL ELEVATION)

5 NOS. OF 32"LED SCREEN AS/APP.

14810WV-RH CHOMOIS TROPICAL MERINO LAMINATE VERTICAL GRAIN ABOVE 19 MM THK. PLY OVER FRAMEWORK

14810WV-RH CHOMOIS TROPICAL MERINO LAMINATE VERTICAL GRAIN ABOVE 19 MM THK. PLY OVER FRAMEWORK

25X25MM MS TUBE FRAMEWORK FINISHED WITH 19MM THK. PLY ABOVE THAT 50X50MM OAK WOOD FRAMEWORK FINISHED WITH NATURAL MATT POLISH & IN BETWEEN FRAMEWORK CORRUGATED SHEET TO BE FIXED PAINTED IN RED & GREY COLOUR

25X25MM MS TUBE FRAMEWORK FINISHED WITH 19MM THK. PLY ABOVE THAT 50X50MM OAK WOOD FRAMEWORK FINISHED WITH NATURAL MATT POLISH & IN BETWEEN FRAMEWORK CORRUGATED SHEET TO BE FIXED PAINTED IN RED & GREY COLOUR

EXISTING MALL FINISH

14810WV-RH CHOMOIS TROPICAL MERINO LAMINATE VERTICAL GRAIN ABOVE 19 MM THK. PLY OVER FRAMEWORK

EXISTING MALL FINISH

14810WV-RH CHOMOIS TROPICAL MERINO LAMINATE VERTICAL GRAIN ABOVE 19 MM THK. PLY OVER FRAMEWORK

WOW MOMO SIGNAGE AS/FRONT ELEVATION

WOW CHINA SIGNAGE AS/FRONT ELEVATION

WALL FINISHES LAYOUT

**PROJECT**

WOW MOMO & WOW CHINA  
@ AHMEDABAD AIRPORT  
FOOD COURT, GUJARAT.

**CLIENT**

WOW MOMO & WOW CHINA

**NOTE:**

THIS DRAWING & DESIGN IS THE COPYRIGHT OF THE DESIGNER. NO PORTION MAY BE REPRODUCED WITHOUT THE WRITTEN PERMISSION OF THE DESIGNERS

1. ALL DIMENSIONS ARE INCLUDING FINISHES
2. DO NOT SCALE DRAWING. ONLY MENTIONED DIMENSIONS ARE TO BE CONSIDERED.
3. ALL DIMENSIONS MUST BE CHECKED BEFORE COMMENCING WORK ON SITE.
4. ANY DISCREPANCIES SHALL BE BROUGHT UNDER THE NOTICE OF ARCHITECTS PRIOR COMMENCEMENT OF WORK.

**REVISION**

S.NO.	REMARKS	DATE
1	REV 1	.....
2	REV 2	
3	REV 3	
4	REV 4	
5	REV 5	
6	REV 6	
7	REV 7	
8	REV 8	

**ARCHITECT / INTERIOR DESIGN**



**CONSULTANT**

.....

**CONSULTANT**

.....

**RELEASE FOR**



INFORMATION	TENDER	CONSTRUCTION	AS BUILT

.....

**TITLE**

GAS ROUTING LAYOUT


DATE	04/10/2023
SCALE	1:25
DRAWN BY	VEDPAL
CHECKED BY	RR.
PRINTED BY	.....
DWG. NO.	IA-112

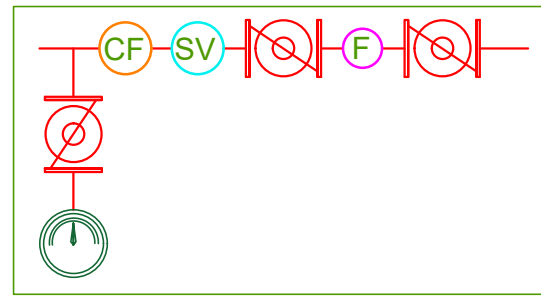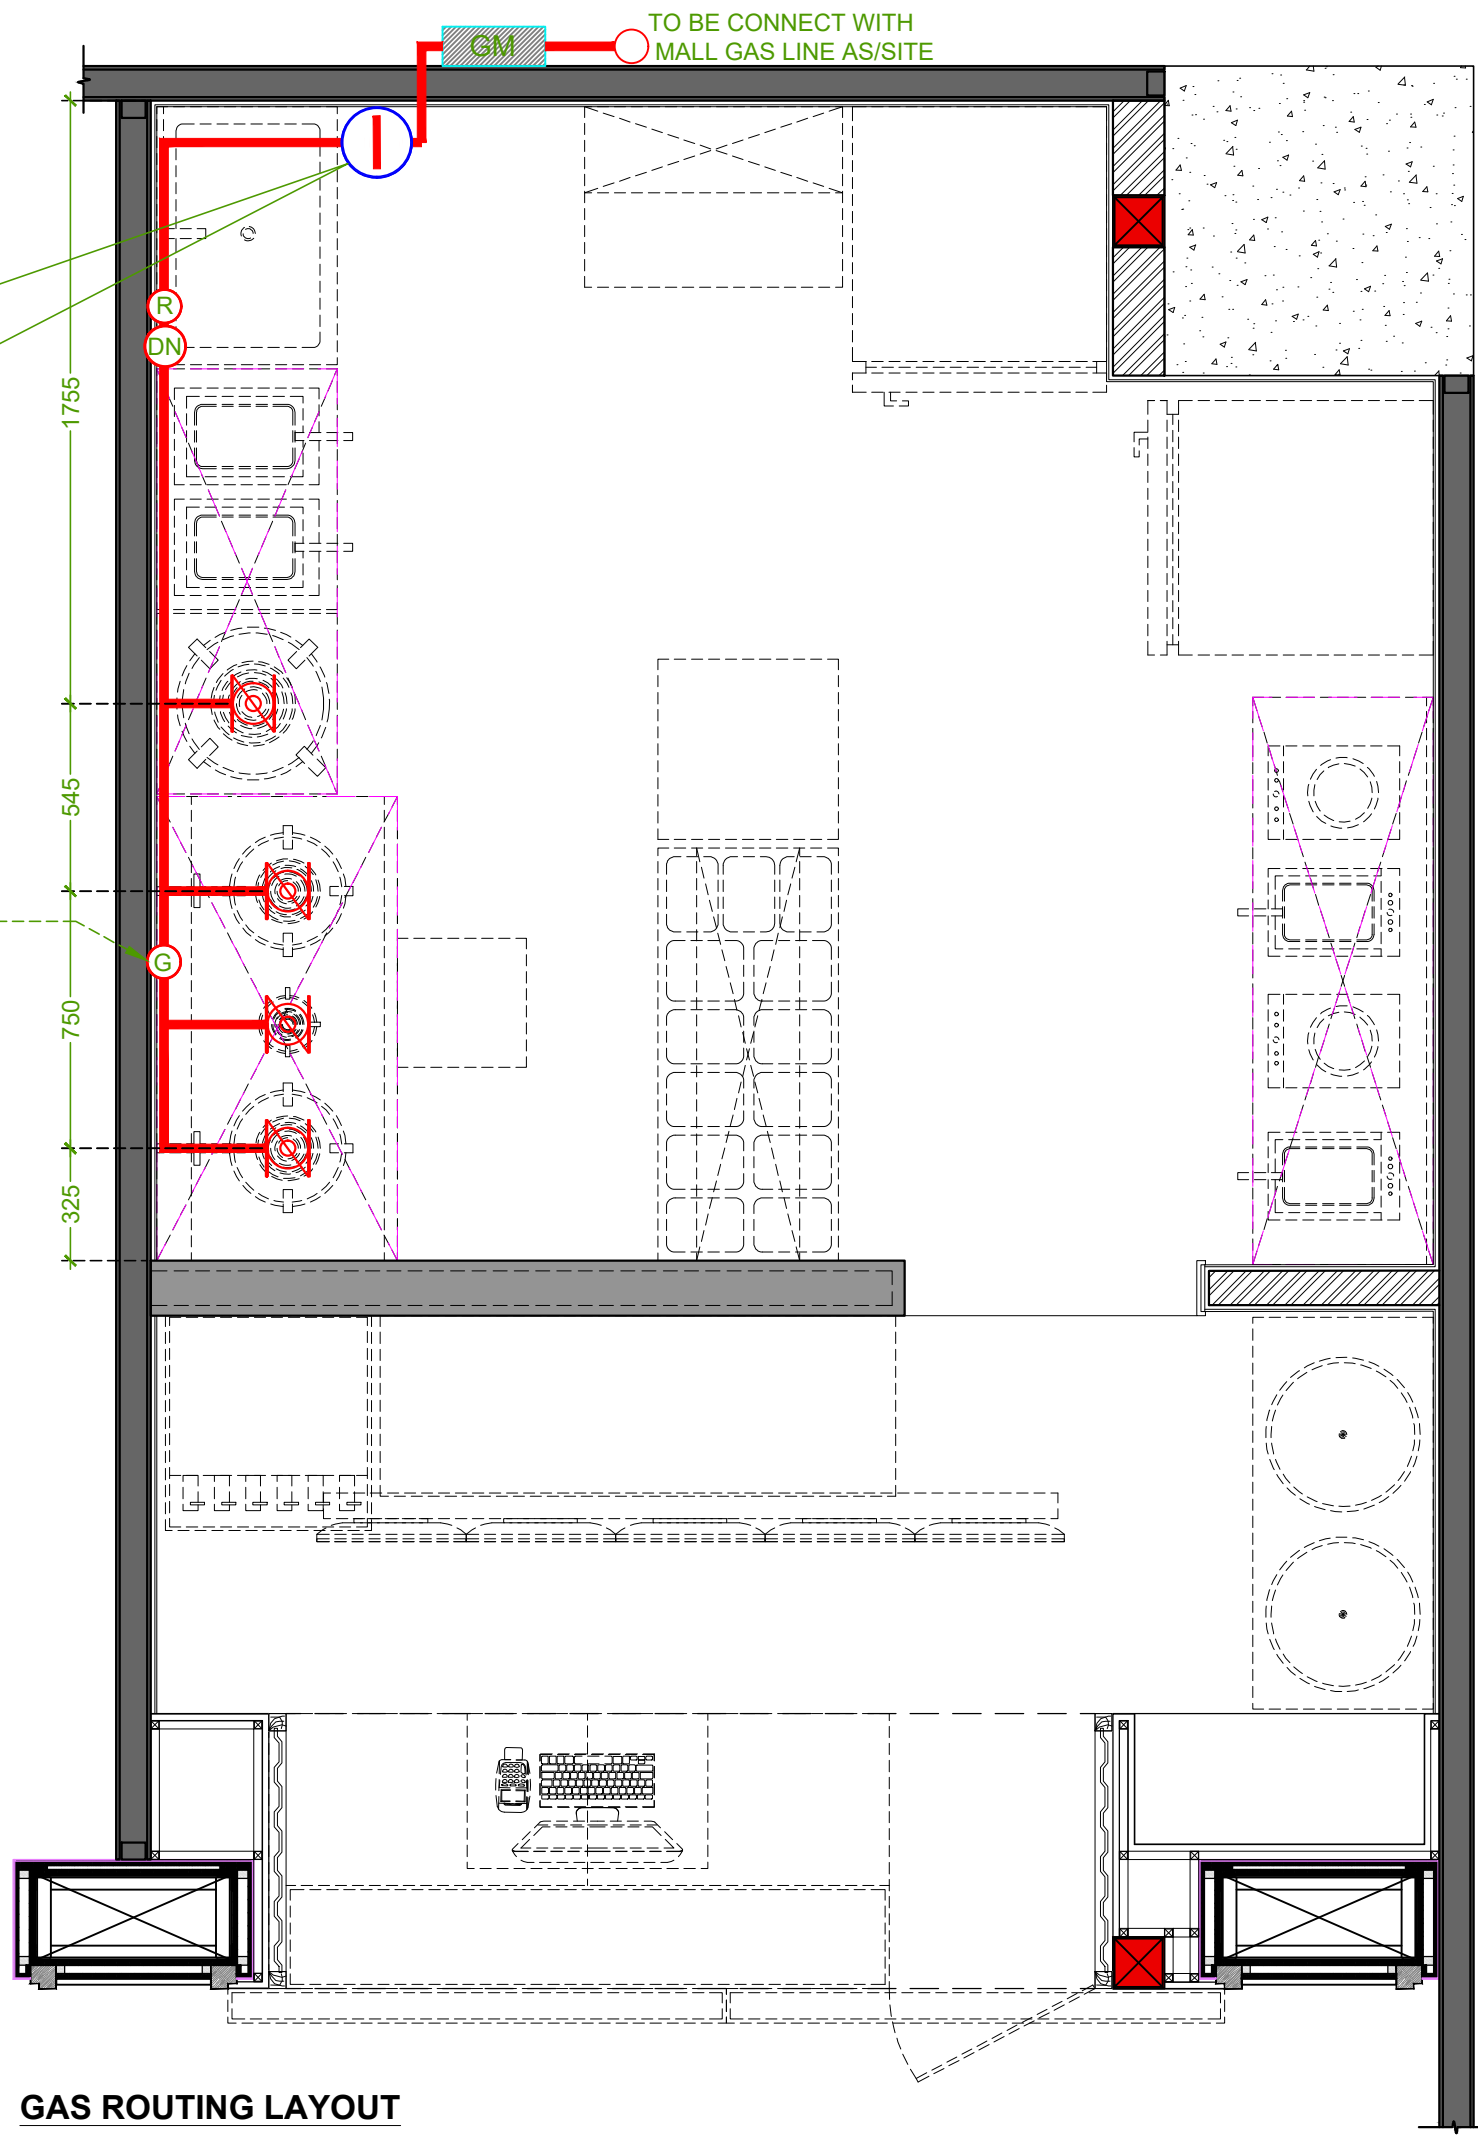

UNI PHUSE  
GLD

GAS LEGEND	
LEGEND	DESCRIPTION
	GAS PIPE
	REGULATOR
	PRESSURE GAUGE
	GAS VALVE
	GAS METER
	GAS LEAKAGE DETECTOR
	FILTER
	COMPACT FILTER
	SOLENOID VALVE 12 VOLT NO
	MMWC PRESSURE GAUGE

**NOTE: GAS DETECTOR TO BE INTERFACED WITH FIRE PANEL OF MALL PANEL.**

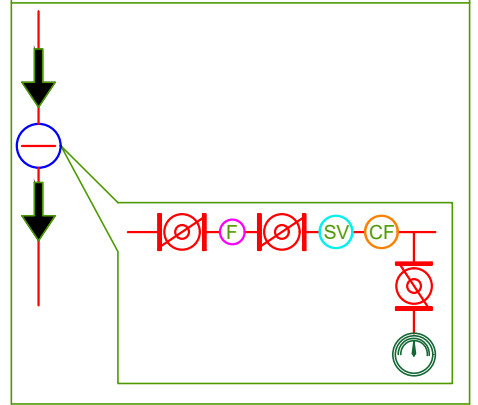

**GAS ROUTING LAYOUT**

**PROJECT**  
 WOW MOMO & WOW CHINA  
 @ AHMEDABAD AIRPORT  
 FOOD COURT, GUJARAT.


**CLIENT**  
 WOW MOMO & WOW CHINA

**NOTE:**  
 THIS DRAWING & DESIGN IS THE COPYRIGHT OF THE DESIGNER. NO PORTION MAY BE REPRODUCED WITHOUT THE WRITTEN PERMISSION OF THE DESIGNERS  
 1. ALL DIMENSIONS ARE INCLUDING FINISHES  
 2. DO NOT SCALE DRAWING. ONLY MENTIONED DIMENSIONS ARE TO BE CONSIDERED.  
 3. ALL DIMENSIONS MUST BE CHECKED BEFORE COMMENCING WORK ON SITE.  
 4. ANY DISCREPANCIES SHALL BE BROUGHT UNDER THE NOTICE OF ARCHITECTS PRIOR COMMENCEMENT OF WORK.

**REVISION**

S.NO.	REMARKS	DATE
1	REV 1	
2	REV 2	
3	REV 3	
4	REV 4	
5	REV 5	
6	REV 6	
7	REV 7	
8	REV 8	

**ARCHITECT / INTERIOR DESIGN**



FLAT NO-13 DDA SFS  
 SLAT POCKET -1 SEC-6 DWARKA,  
 NEW DELHI-110075  
 EMAIL:-info@osts.com  
 OFF-011-35559249, MOB-9910315171

**CONSULTANT**  
 \_\_\_\_\_  
 \_\_\_\_\_

**RELEASE FOR**


INFORMATION	TENDER	CONSTRUCTION	AS BUILT

**TITLE**  
 CCTV LAYOUT

DATE	04/10/2023
SCALE	1:25
DRAWN BY	VEDPAL
CHECKED BY	RR.
PRINTED BY	_____
DWG. NO.	IA-113

**CCTV LEGEND**


S.NO.	DESCRIPTION	QTY.
1	NIGHT VISION CAMERA	05
2	DVR WITH PC	01
3	MONITOR	01
4	SERVER RACK	01

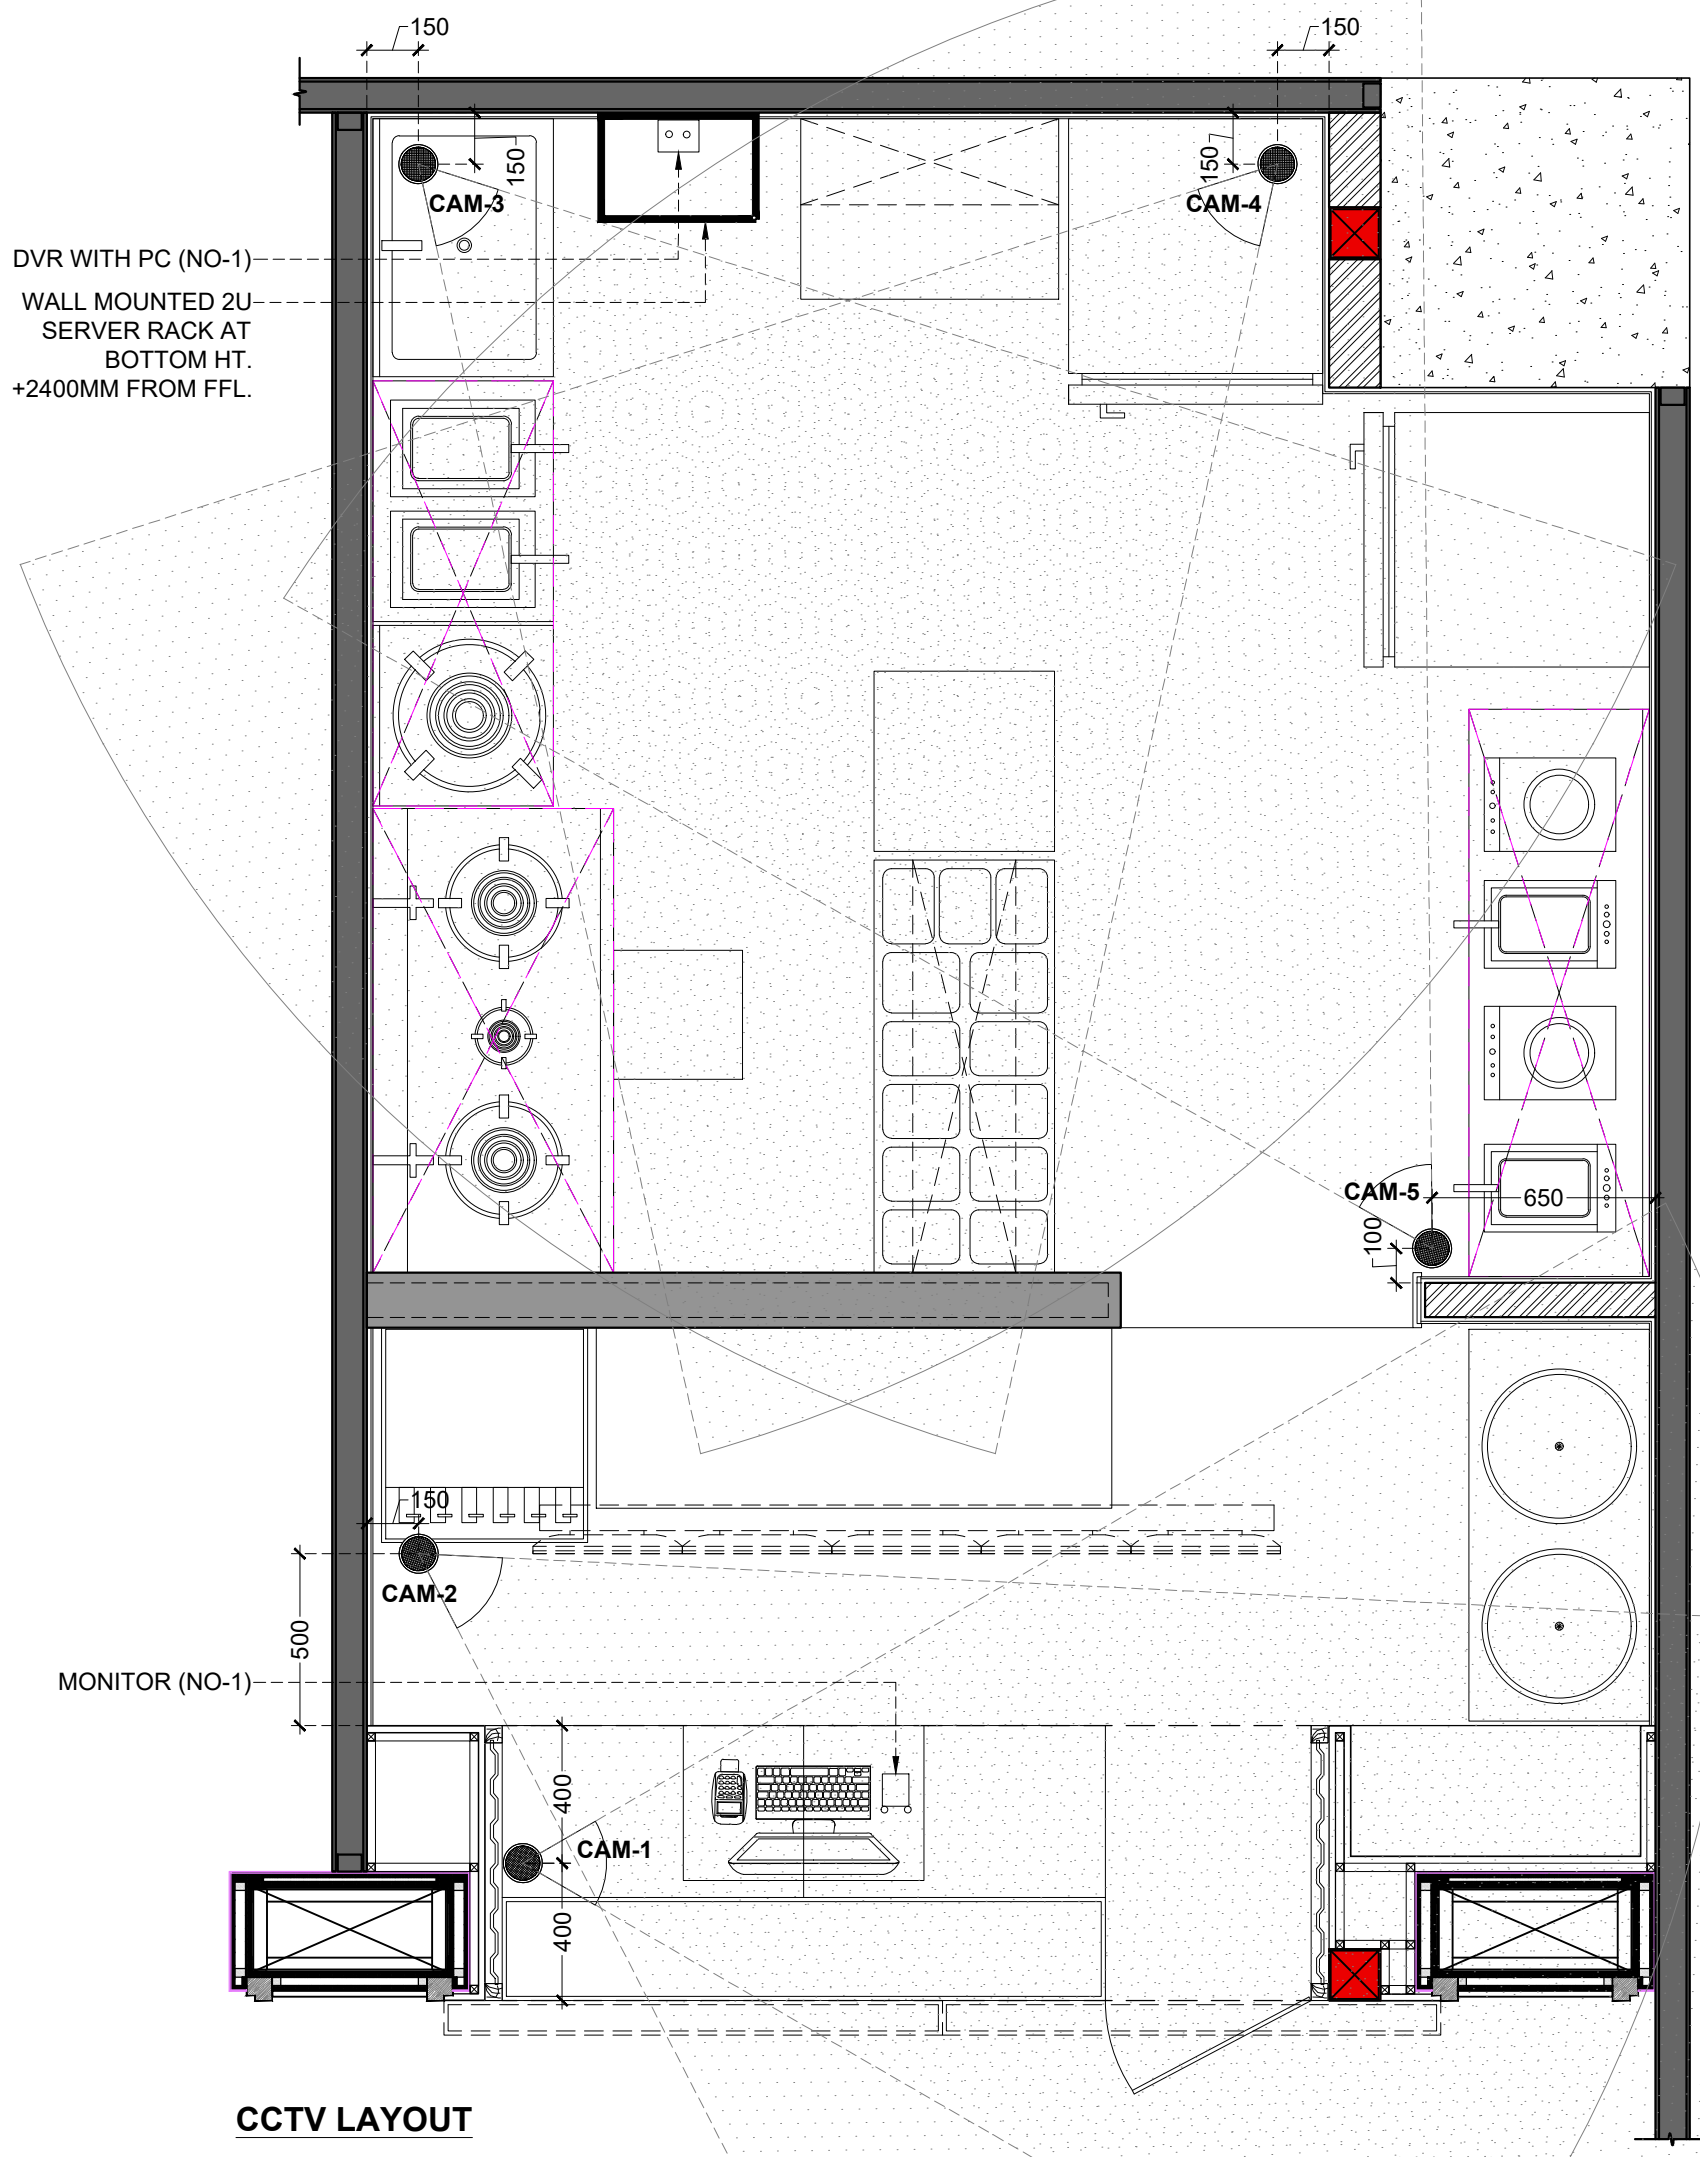

DVR WITH PC (NO-1)  
 WALL MOUNTED 2U  
 SERVER RACK AT  
 BOTTOM HT.  
 +2400MM FROM FFL.

MONITOR (NO-1)

**CCTV LAYOUT**

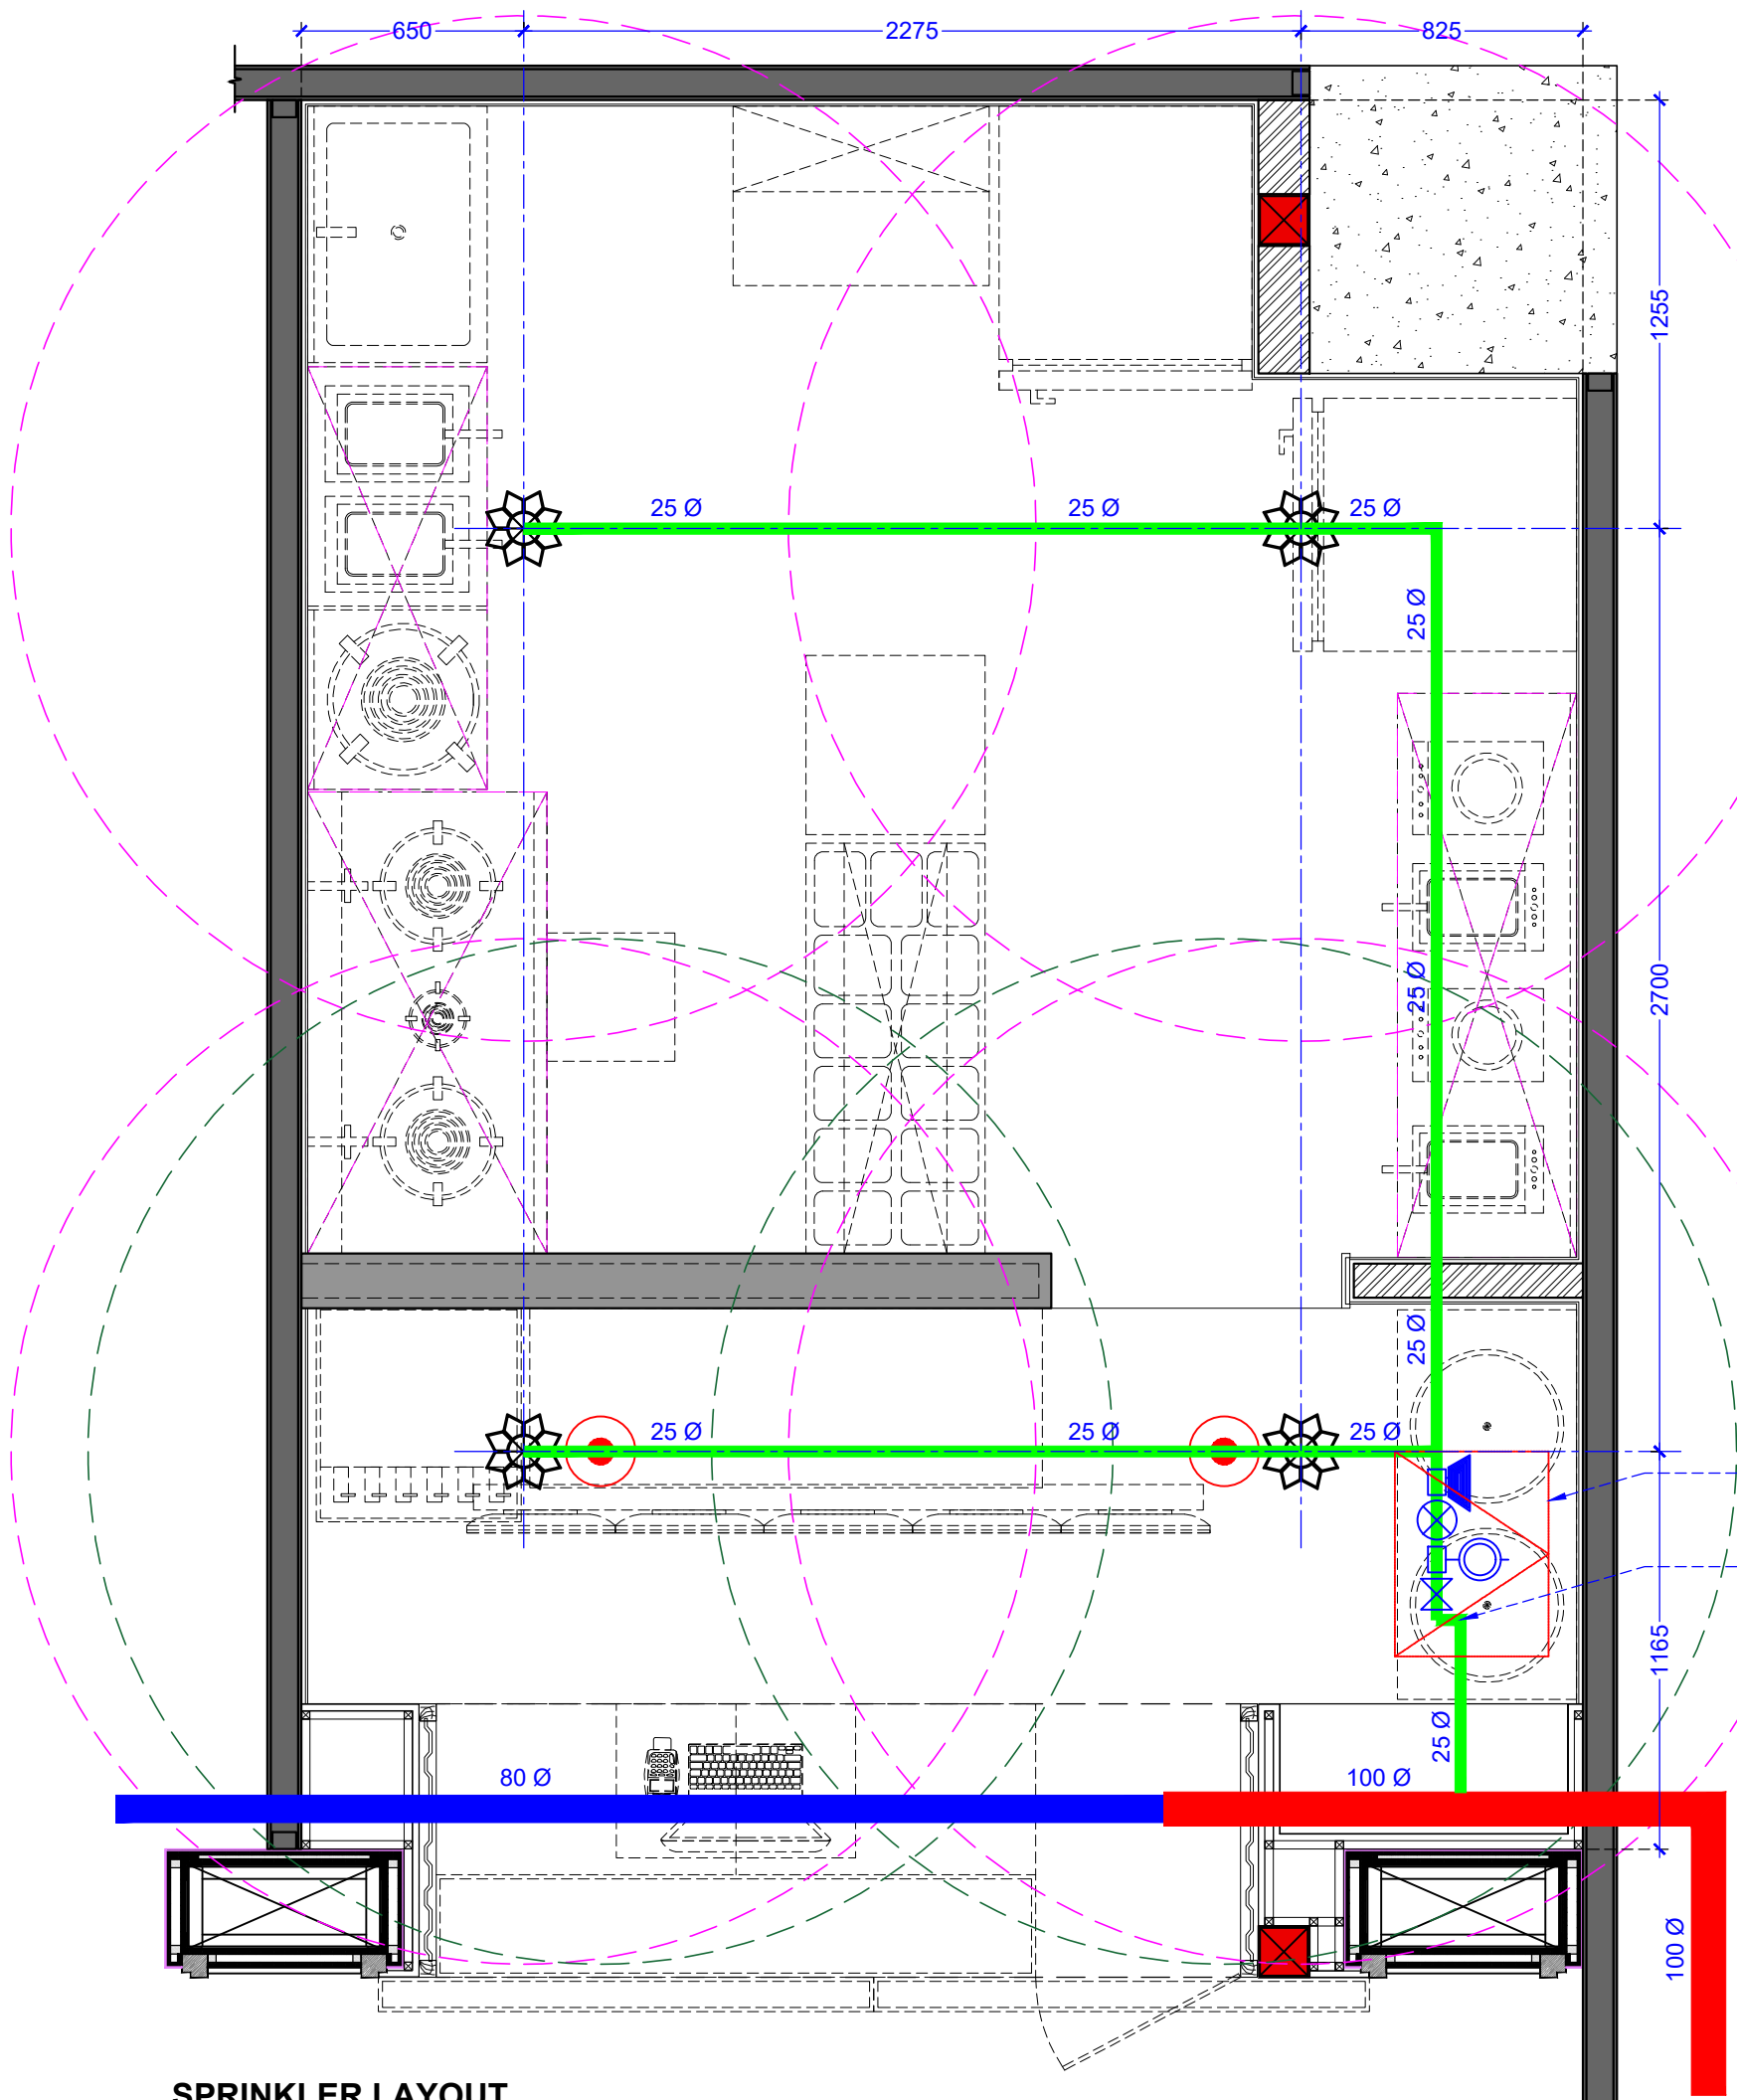

FIRE FIGHTING LEGEND			
S.NO.	ITEMS	DESCRIPTION	QTY.
1.		SPRINKLER BELOW FALSE CEILING	04
2.		SPRINKLER ABOVE FALSE CEILING	02
3.		SPRINKLER COVERING 3000 Ø MM	
4.		SPRINKLER COVERING 3000 Ø MM	
5.		FLOW SWITCH	
6.		BUTTERFLY VALVE	
7.		PRESSURE GAUGE	
8.		TEMPER SWITCH	

**PROJECT**  
 WOW MOMO & WOW CHINA  
 @ AHMEDABAD AIRPORT  
 FOOD COURT, GUJARAT.

**CLIENT**  
 WOW MOMO & WOW CHINA

**NOTE:**  
 THIS DRAWING & DESIGN IS THE COPYRIGHT OF THE DESIGNER. NO PORTION MAY BE REPRODUCED WITHOUT THE WRITTEN PERMISSION OF THE DESIGNERS

1. ALL DIMENSIONS ARE INCLUDING FINISHES
2. DO NOT SCALE DRAWING. ONLY MENTIONED DIMENSIONS ARE TO BE CONSIDERED.
3. ALL DIMENSIONS MUST BE CHECKED BEFORE COMMENCING WORK ON SITE.
4. ANY DISCREPANCIES SHALL BE BROUGHT UNDER THE NOTICE OF ARCHITECTS PRIOR COMMENCEMENT OF WORK.

REVISION		
S.NO.	REMARKS	DATE
1	REV 1	
2	REV 2	
3	REV 3	
4	REV 4	
5	REV 5	
6	REV 6	
7	REV 7	
8	REV 8	

**ARCHITECT / INTERIOR DESIGN**

FLAT NO-13 DDA SFS  
 SLAT POCKET -1 SEC-6 DWARKA,  
 NEW DELHI-110075  
 EMAIL:-infoatats@gmail.com  
 OFF-011-35559249, MOB-9910315171

**CONSULTANT**  
 \_\_\_\_\_

**CONSULTANT**  
 \_\_\_\_\_

**RELEASE FOR**


INFORMATION	TENDER	CONSTRUCTION	AS BUILT
-------------	--------	--------------	----------

**TITLE**  
 SPRINKLER LAYOUT

DATE	04/10/2023
SCALE	1:25
DRAWN BY	VEDPAL
CHECKED BY	RR.
PRINTED BY	_____
DWG. NO.	IA-114

**SPRINKLER LAYOUT**



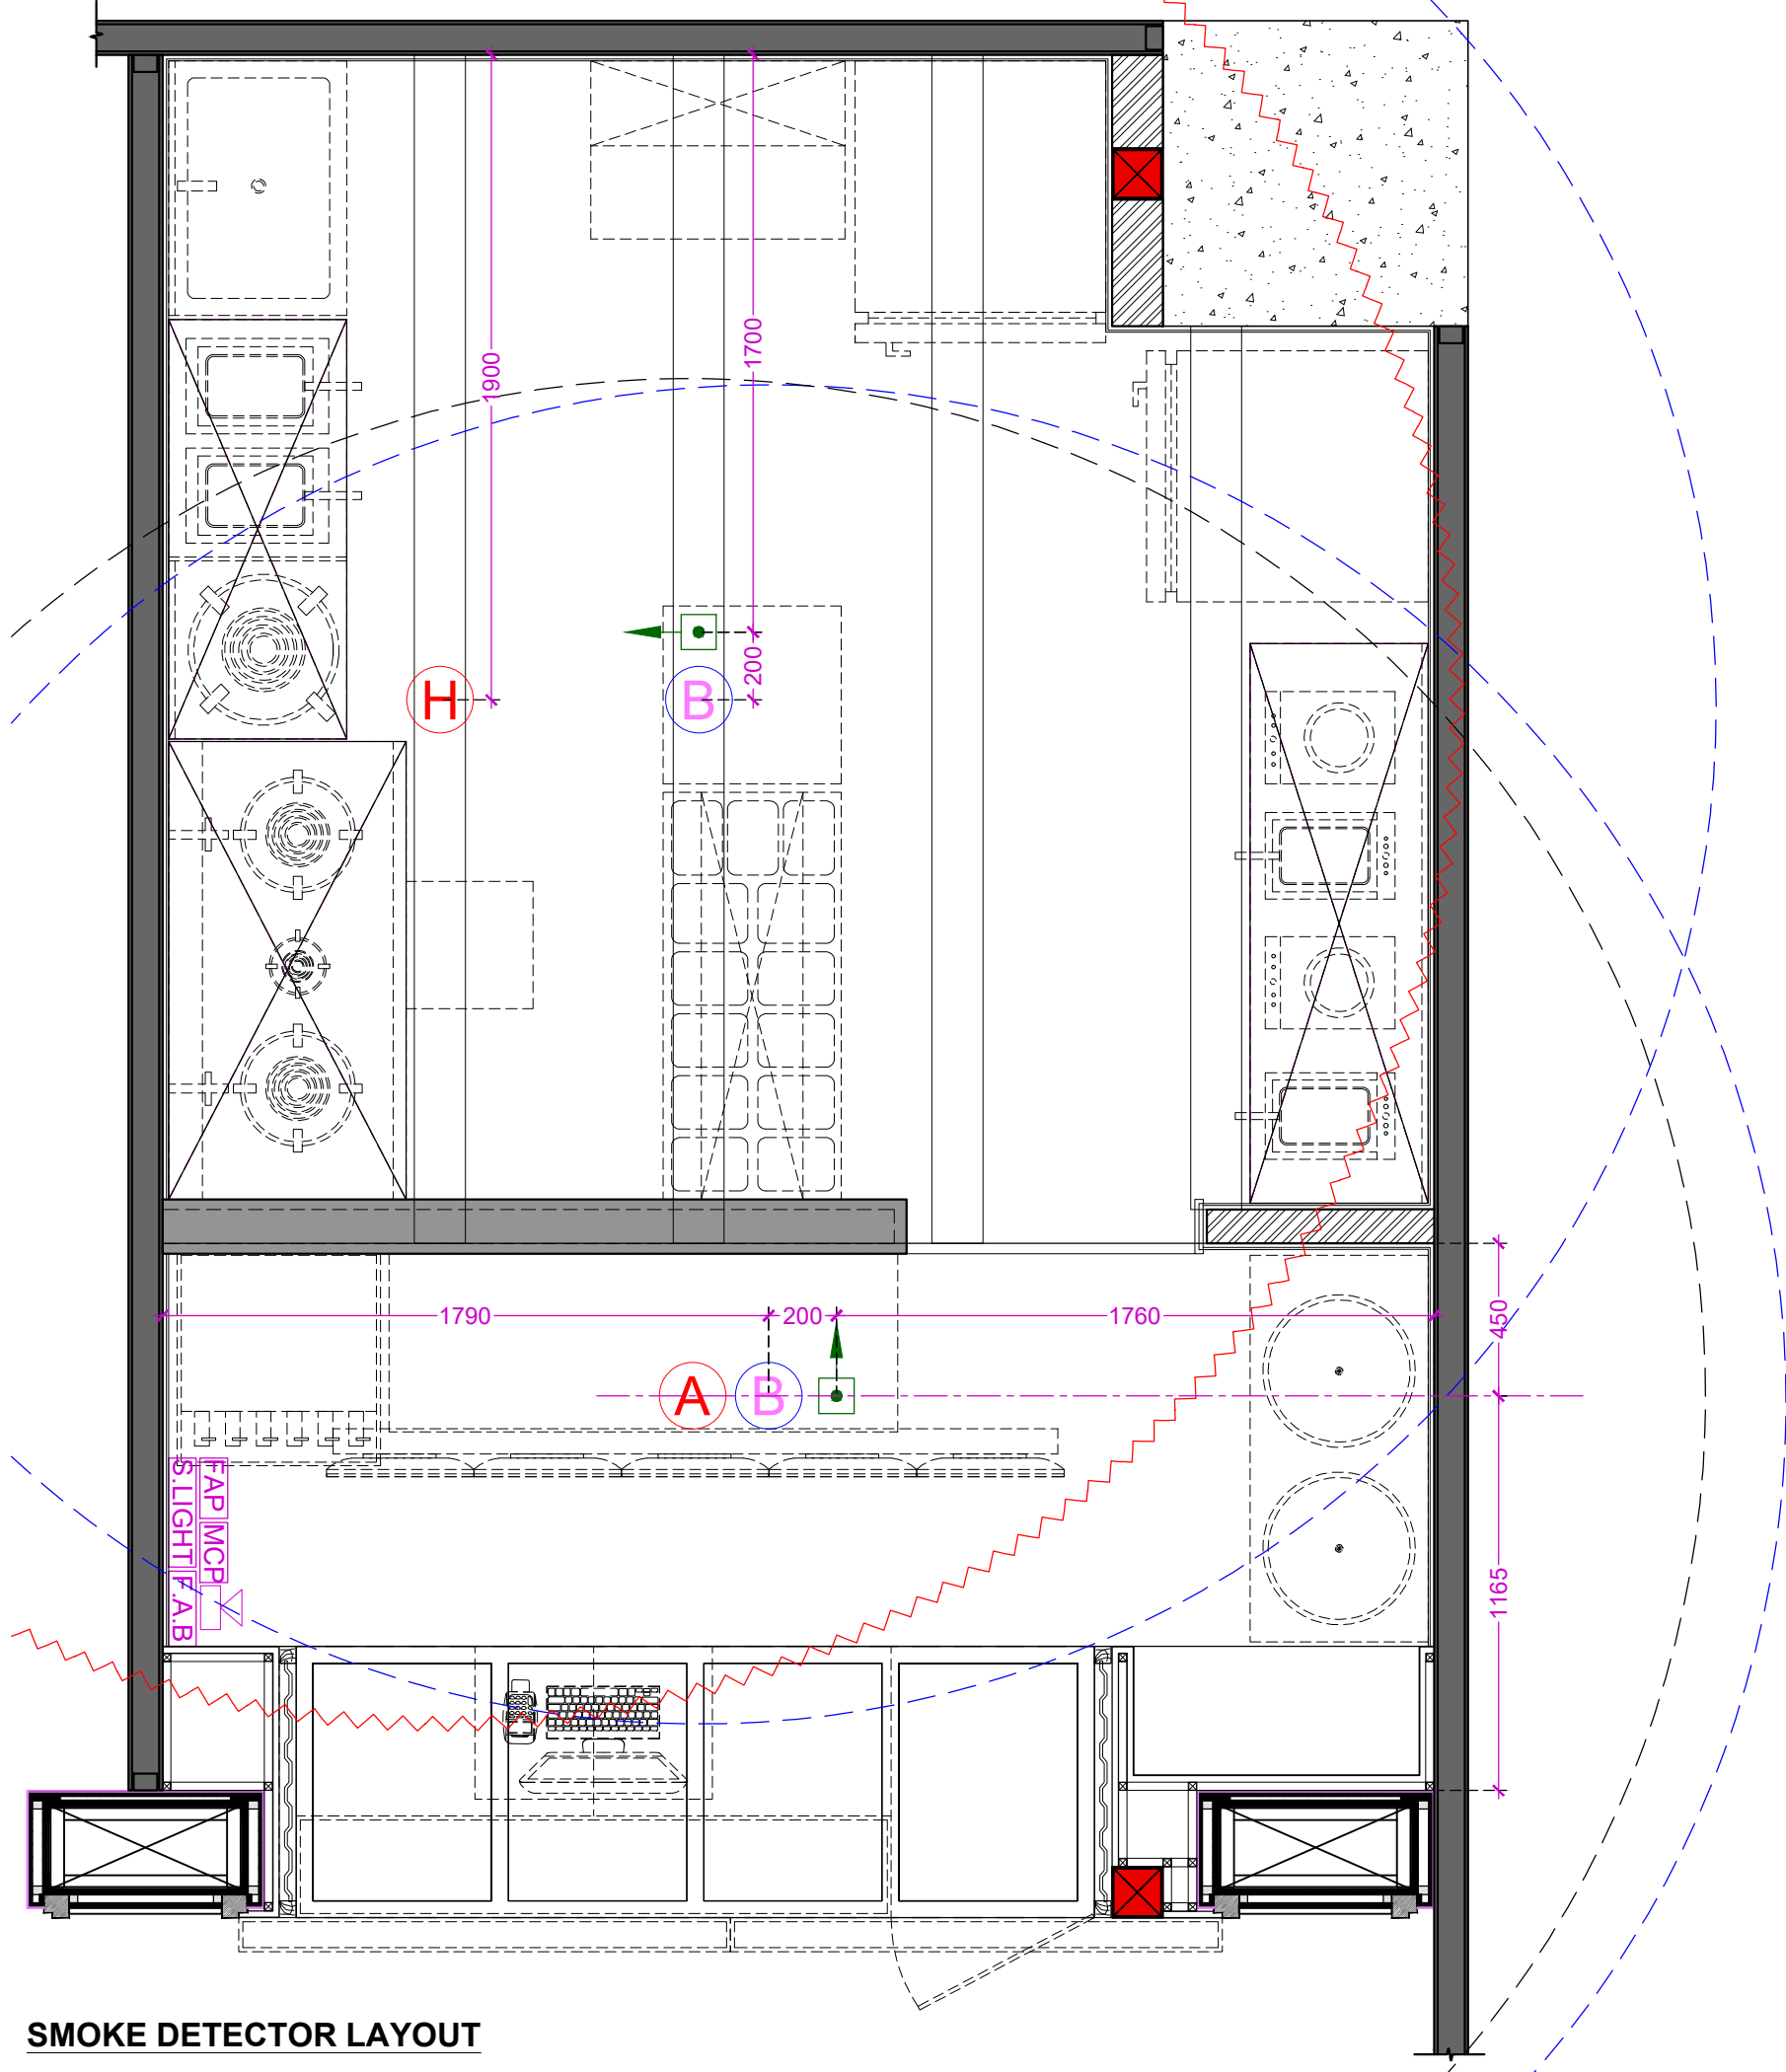

SMOKE DETECTOR LEGEND			
S.NO.	ITEMS	DESCRIPTION	QTY.
1.	(A)	SMOKE DETECTOR ABOVE FALSE CEILING	01
2.	(B)	SMOKE DETECTOR BELOW FALSE CEILING	02
3.	(H)	CONVENTIONAL HEAT DETECTOR	01
4.		RESPONSE INDICATOR	02
5.		HOOTER	01
6.	MCP	MANUAL CALL POINT	01
7.	FAP	FIRE ALARM PANEL	01
8.	S.LIGHT	STROBE LIGHT	01
9.	F.A.B	FIRST AID BOX	01

**PROJECT**  
 WOW MOMO & WOW CHINA  
 @ AHMEDABAD AIRPORT  
 FOOD COURT, GUJARAT.

**CLIENT**  
 WOW MOMO & WOW CHINA

**NOTE:**  
 THIS DRAWING & DESIGN IS THE COPYRIGHT OF THE DESIGNER. NO PORTION MAY BE REPRODUCED WITHOUT THE WRITTEN PERMISSION OF THE DESIGNERS

1. ALL DIMENSIONS ARE INCLUDING FINISHES
2. DO NOT SCALE DRAWING. ONLY MENTIONED DIMENSIONS ARE TO BE CONSIDERED.
3. ALL DIMENSIONS MUST BE CHECKED BEFORE COMMENCING WORK ON SITE.
4. ANY DISCREPANCIES SHALL BE BROUGHT UNDER THE NOTICE OF ARCHITECTS PRIOR COMMENCEMENT OF WORK.

**REVISION**

S.NO.	REMARKS	DATE
1	REV 1	.....
2	REV 2	.....
3	REV 3	.....
4	REV 4	.....
5	REV 5	.....
6	REV 6	.....
7	REV 7	.....
8	REV 8	.....

**ARCHITECT / INTERIOR DESIGN**

FLAT NO-13 DDA SFS  
 SLAT POCKET -1 SEC-6 DWARKA,  
 NEW DELHI-110075  
 EMAIL:-infoatats@gmail.com  
 OFF-011-35559249, MOB-9910315171

**CONSULTANT**  
 \_\_\_\_\_

**CONSULTANT**  
 \_\_\_\_\_

**RELEASE FOR**

INFORMATION	TENDER	CONSTRUCTION	AS BUILT
.....	.....	.....	.....


**TITLE**  
 SMOKE DETECTOR LAYOUT

DATE	04/10/2023
SCALE	1:25
DRAWN BY	VEDPAL
CHECKED BY	RR.
PRINTED BY	.....
DWG. NO.	IA-115

**SMOKE DETECTOR LAYOUT**

EXHAUST DUCT TO BE CONNECTED (AS/SITE CONDITION) 5000 CFM

FRESH DUCT TO BE CONNECTED (AS/SITE CONDITION) 4200 CFM

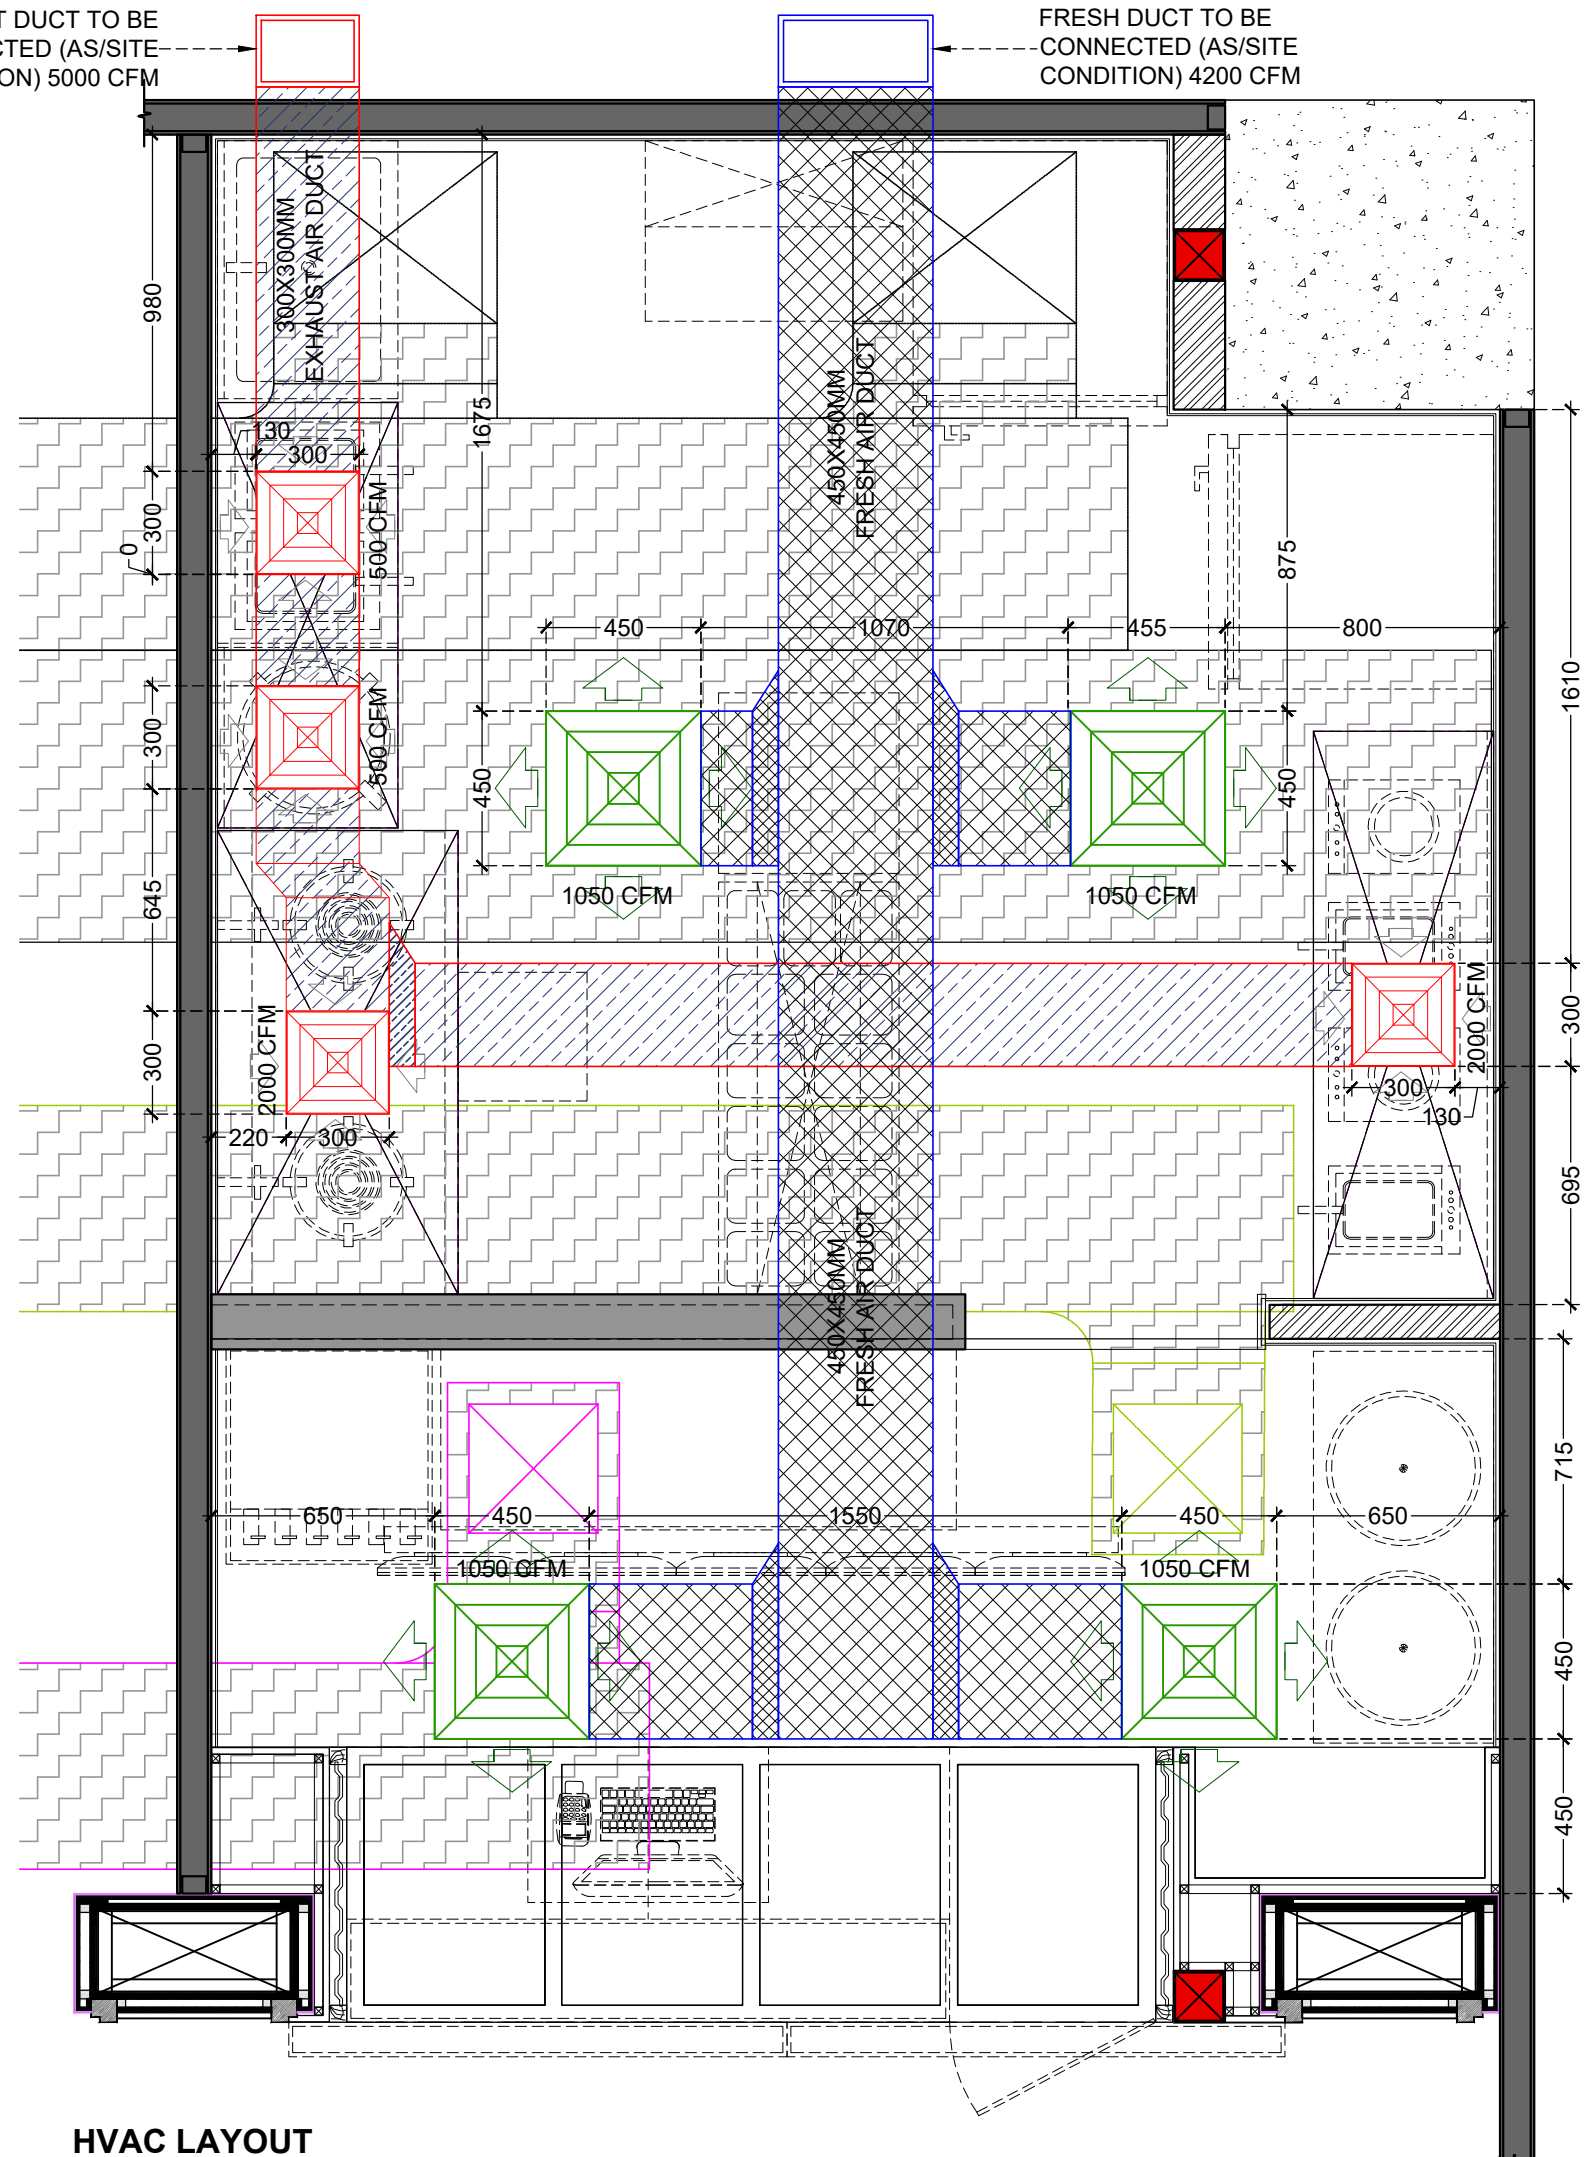

HVAC LEGEND	
	EXHAUST DUCT
	EXHAUST GRILL
	EXHAUST DUCT
	FRESH AIR GRILL
	EXISTING DUCT AS/SITE

**PROJECT**  
 WOW MOMO & WOW CHINA  
 @ AHMEDABAD AIRPORT  
 FOOD COURT, GUJARAT.

**CLIENT**  
 WOW MOMO & WOW CHINA

**NOTE:**  
 THIS DRAWING & DESIGN IS THE COPYRIGHT OF THE DESIGNER. NO PORTION MAY BE REPRODUCED WITHOUT THE WRITTEN PERMISSION OF THE DESIGNERS

1. ALL DIMENSIONS ARE INCLUDING FINISHES
2. DO NOT SCALE DRAWING. ONLY MENTIONED DIMENSIONS ARE TO BE CONSIDERED.
3. ALL DIMENSIONS MUST BE CHECKED BEFORE COMMENCING WORK ON SITE.
4. ANY DISCREPANCIES SHALL BE BROUGHT UNDER THE NOTICE OF ARCHITECTS PRIOR COMMENCEMENT OF WORK.

REVISION		
S.NO.	REMARKS	DATE
1	REV 1	
2	REV 2	
3	REV 3	
4	REV 4	
5	REV 5	
6	REV 6	
7	REV 7	
8	REV 8	

**ARCHITECT / INTERIOR DESIGN**

FLAT NO-13 DDA SFS  
 SLAT POCKET -1 SEC-6 DWARKA,  
 NEW DELHI-110075  
 EMAIL:-infoatats@gmail.com  
 OFF-011-35559249, MOB-9910315171

**CONSULTANT**  
 \_\_\_\_\_

**CONSULTANT**  
 \_\_\_\_\_


**RELEASE FOR**

INFORMATION	TENDER	CONSTRUCTION	AS BUILT
-------------	--------	--------------	----------

**TITLE**  
 HVAC LAYOUT

DATE	04/10/2023
SCALE	1:25
DRAWN BY	VEDPAL
CHECKED BY	RR.
PRINTED BY	_____
DWG. NO.	IA-116

**HVAC LAYOUT**

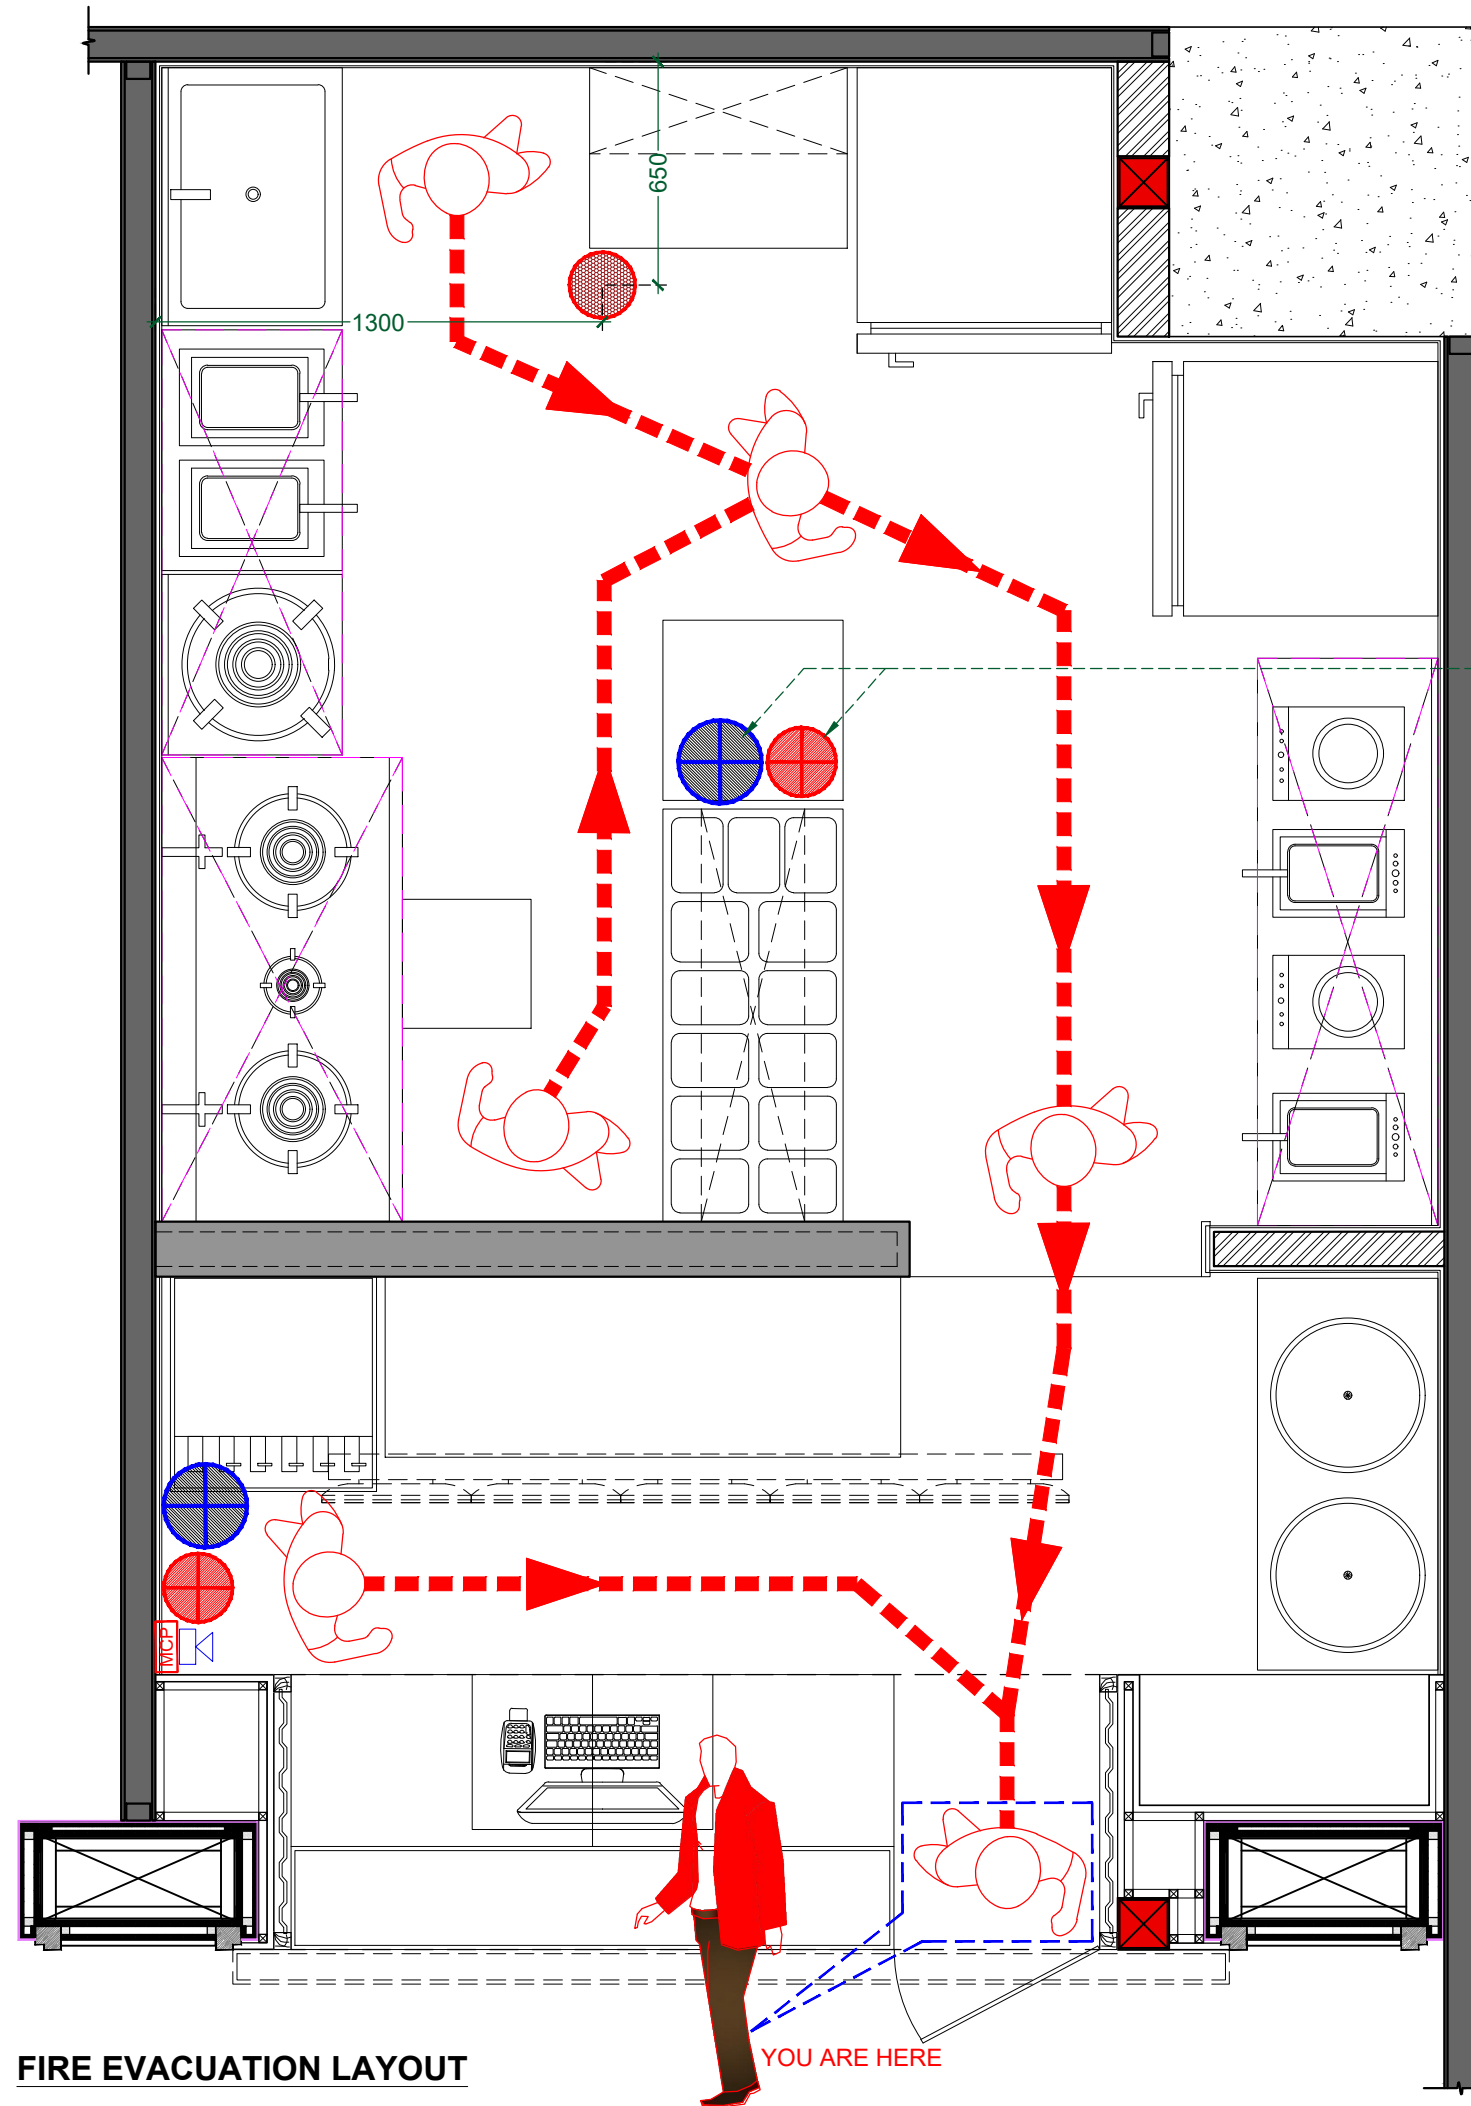

FIRE EXTINGUISHER  
CYLINDERS PUT UNDER  
WORKING TABLE

**FIRE LEGEND**

	MANUAL CALL POINT
	HOOTER
	FIRE EXTINGUISHER ABC 4 K.G. CO <sub>2</sub> CYLINDER (2-NO)
	FIRE EXTINGUISHER "K" TYPE 6 K.G. CO <sub>2</sub> CYLINDER (2-NO)
	CEILING MOUNTED AUTOMATIC ABC DRY POWDER TYPE (1-NO)

- NOTE:-**
1. FIRE EXTINGUISHER SHALL CONFIRM TO RELEVANT LATEST INDIAN STANDARD.
  2. FIRE EXTINGUISHER SHALL BE HUNG ON BRACKETS WITH THEIR BOTTOM 750 MM ABOVE FLOOR LEVEL.
  3. THE EXACT LOCATION OF FIRE EXTINGUISHERS SHALL BE AS/DRAWING.

**FIRE EVACUATION LAYOUT**

YOU ARE HERE

**PROJECT**

WOW MOMO & WOW CHINA  
@ AHMEDABAD AIRPORT  
FOOD COURT, GUJARAT.

**CLIENT**

WOW MOMO & WOW CHINA

**NOTE:**

THIS DRAWING & DESIGN IS THE COPYRIGHT OF THE DESIGNER. NO PORTION MAY BE REPRODUCED WITHOUT THE WRITTEN PERMISSION OF THE DESIGNERS

1. ALL DIMENSIONS ARE INCLUDING FINISHES
2. DO NOT SCALE DRAWING. ONLY MENTIONED DIMENSIONS ARE TO BE CONSIDERED.
3. ALL DIMENSIONS MUST BE CHECKED BEFORE COMMENCING WORK ON SITE.
4. ANY DISCREPANCIES SHALL BE BROUGHT UNDER THE NOTICE OF ARCHITECTS PRIOR COMMENCEMENT OF WORK.

**REVISION**

S.NO.	REMARKS	DATE
1	REV 1	.....
2	REV 2	
3	REV 3	
4	REV 4	
5	REV 5	
6	REV 6	
7	REV 7	
8	REV 8	

**ARCHITECT / INTERIOR DESIGN**



FLAT NO-13 DDA SFS  
SLAT POCKET -1 SEC-6 DWARKA,  
NEW DELHI-110075  
EMAIL:-infoatats@gmail.com  
OFF-011-35559249, MOB-9910315171

**CONSULTANT**

**CONSULTANT**


**RELEASE FOR**

INFORMATION | TENDER | CONSTRUCTION | AS BUILT

**TITLE**

FIRE EVACUATION LAYOUT

DATE	04/10/2023
SCALE	1:25
DRAWN BY	VEDPAL
CHECKED BY	RR.
PRINTED BY	.....
DWG. NO.	IA-117

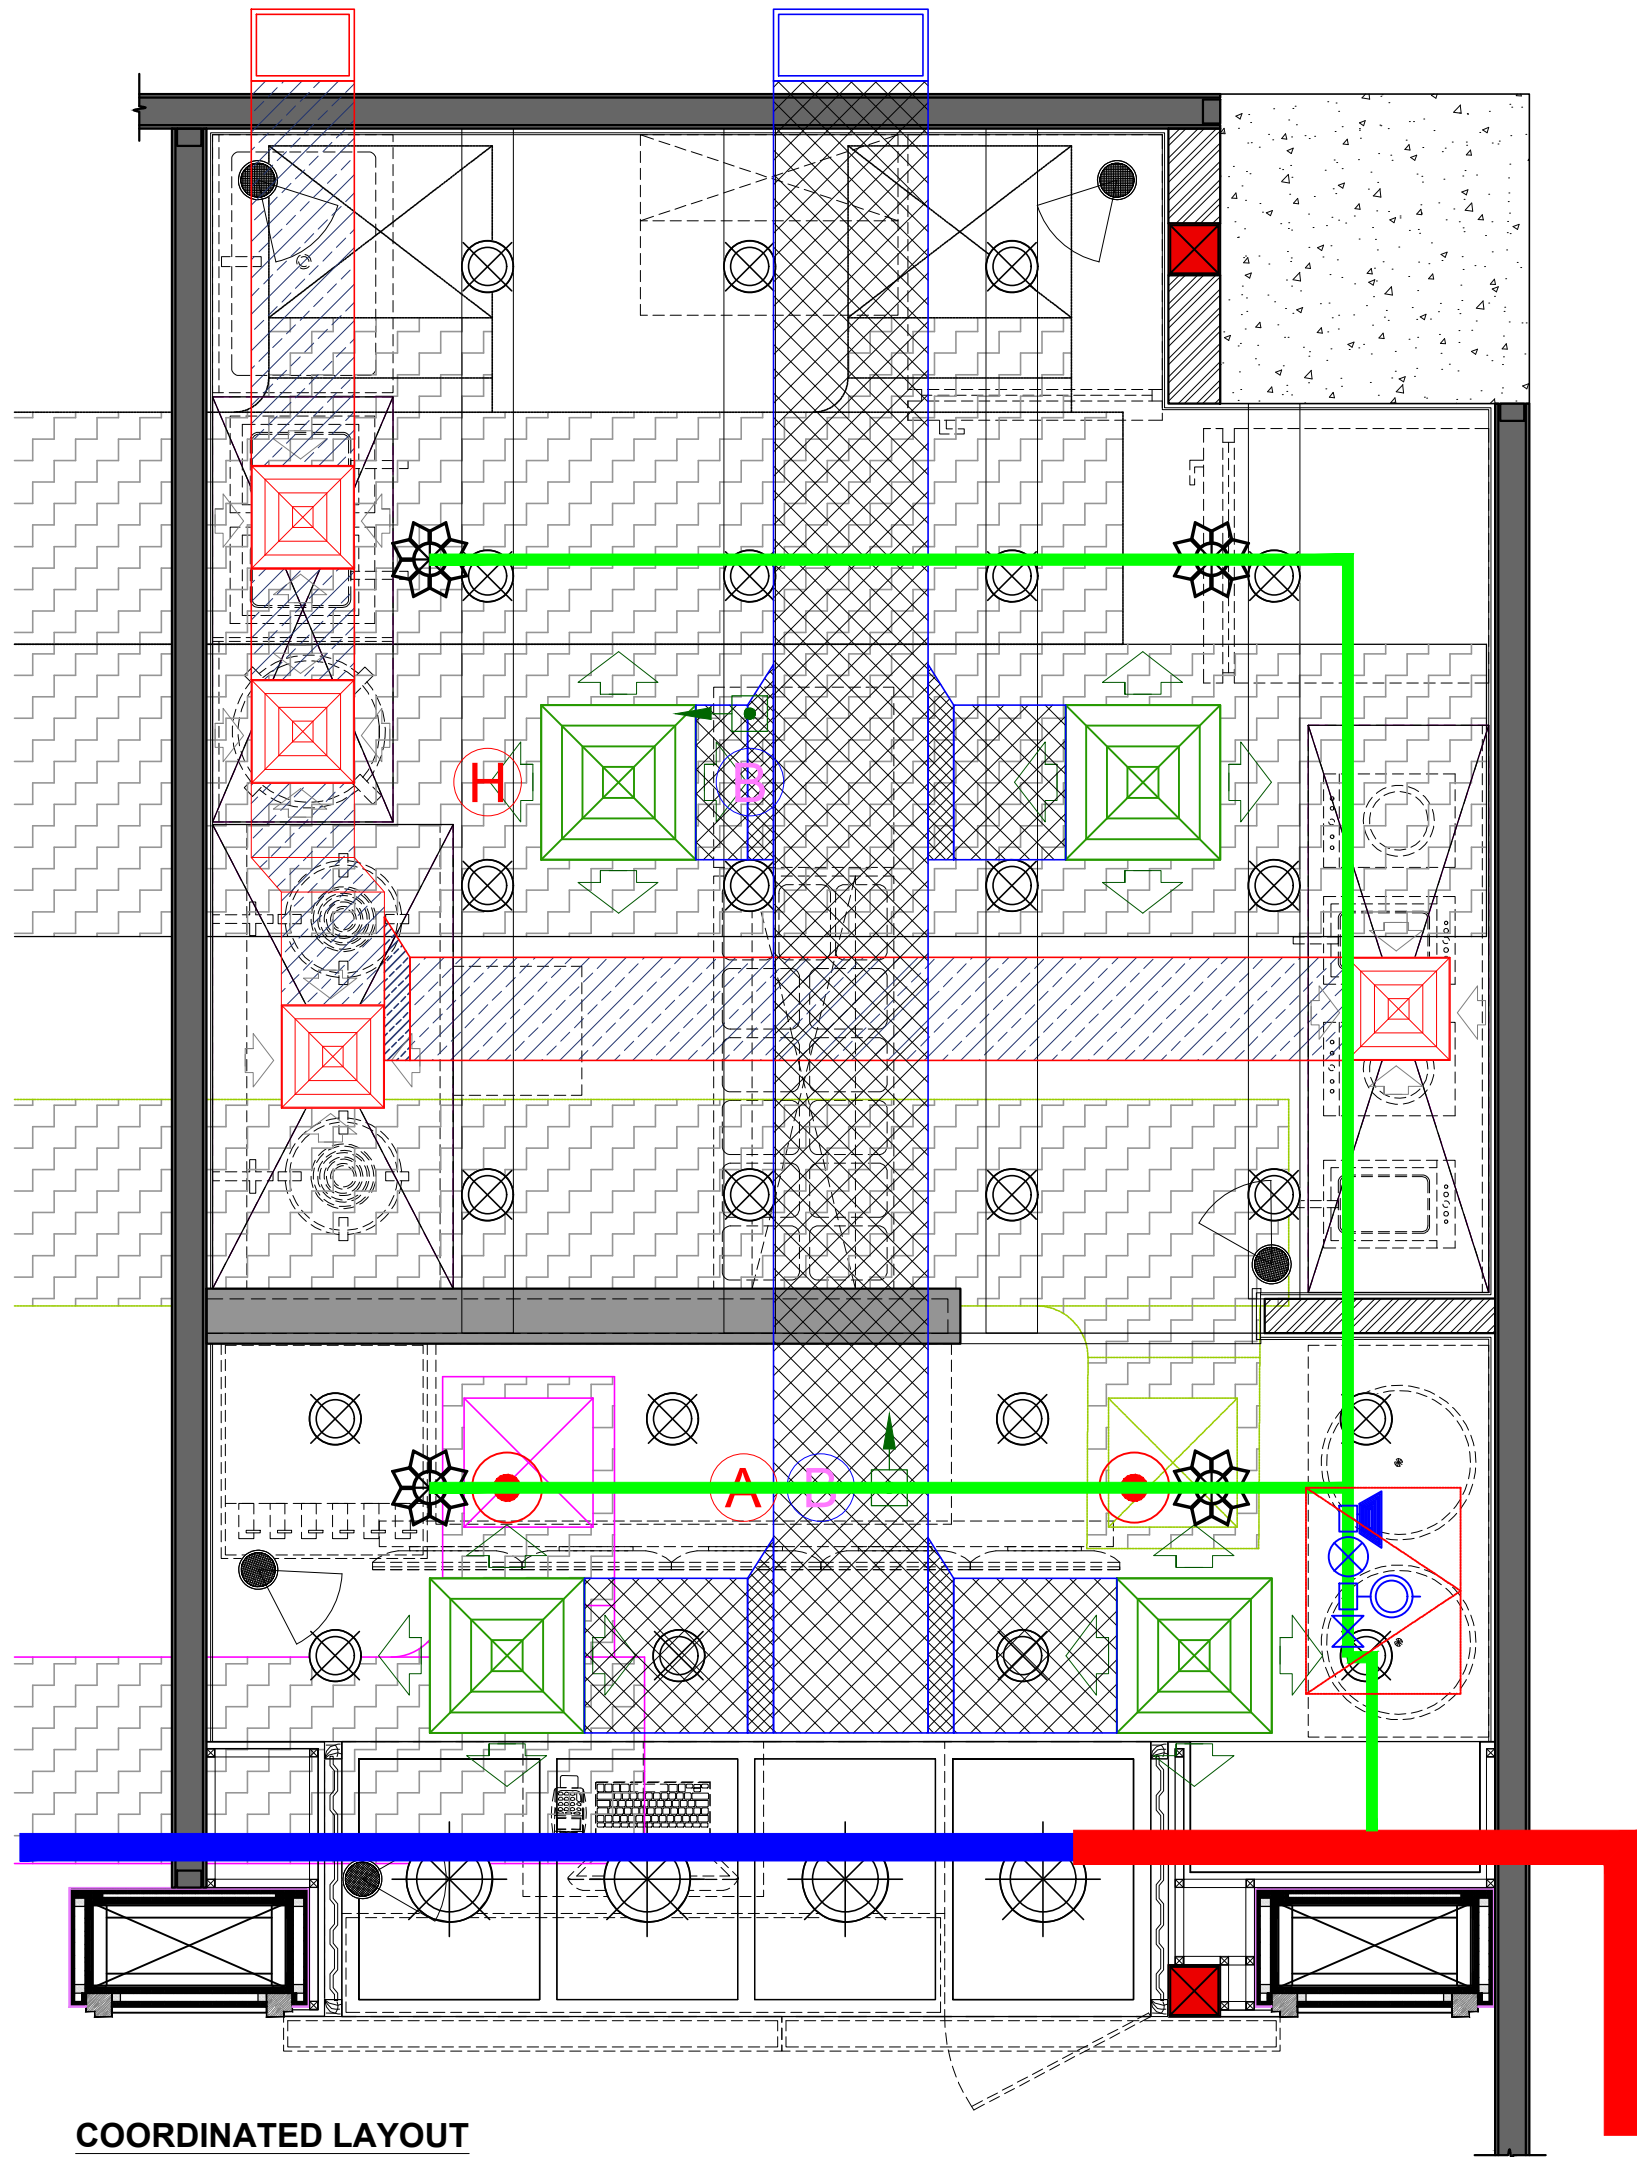

FIRE FIGHTING LEGEND			
S.NO.	ITEMS	DESCRIPTION	QTY.
1.		SPRINKLER BELOW FALSE CEILING	04
2.		SPRINKLER ABOVE FALSE CEILING	02
3.		SPRINKLER COVERING 3000 Ø MM	
4.		SPRINKLER COVERING 3000 Ø MM	
5.		FLOW SWITCH	
6.		BUTTERFLY VALVE	
7.		PRESSURE GAUGE	
8.		TEMPER SWITCH	

SMOKE DETECTOR LEGEND			
S.NO.	ITEMS	DESCRIPTION	QTY.
1.		SMOKE DETECTOR ABOVE FALSE CEILING	01
2.		SMOKE DETECTOR BELOW FALSE CEILING	02
3.		CONVENTIONAL HEAT DETECTOR	01
4.		RESPONSE INDICATOR	02

CCTV LEGEND		
S.NO.	DESCRIPTION	QTY.
	NIGHT VISION CAMERA	05
	DVR WITH PC	01
	MONITOR	01
	SERVER RACK	01

LIGHTING LEGEND		
S.NO.	DESCRIPTION	QTY.
	150MM Ø SURFACE LIGHT	23
	300 MM Ø HANGING LIGHT	04
EL	EMEGENCY LIGHT	

HVAC LEGEND	
	EXHAUST DUCT
	EXHAUST GRILL
	EXHAUST DUCT
	FRESH AIR GRILL
	EXISTING DUCT AS/SITE

**PROJECT**  
 WOW MOMO & WOW CHINA  
 @ AHMEDABAD AIRPORT  
 FOOD COURT, GUJARAT.

**CLIENT**  
 WOW MOMO & WOW CHINA

**NOTE:**  
 THIS DRAWING & DESIGN IS THE COPYRIGHT OF THE DESIGNER. NO PORTION MAY BE REPRODUCED WITHOUT THE WRITTEN PERMISSION OF THE DESIGNERS

1. ALL DIMENSIONS ARE INCLUDING FINISHES
2. DO NOT SCALE DRAWING. ONLY MENTIONED DIMENSIONS ARE TO BE CONSIDERED.
3. ALL DIMENSIONS MUST BE CHECKED BEFORE COMMENCING WORK ON SITE.
4. ANY DISCREPANCIES SHALL BE BROUGHT UNDER THE NOTICE OF ARCHITECTS PRIOR COMMENCEMENT OF WORK.

REVISION		
S.NO.	REMARKS	DATE
1	REV 1	
2	REV 2	
3	REV 3	
4	REV 4	
5	REV 5	
6	REV 6	
7	REV 7	
8	REV 8	

**ARCHITECT / INTERIOR DESIGN**

FLAT NO-13 DDA SFS  
 SLAT POCKET -1 SEC-6 DWARKA,  
 NEW DELHI-110075  
 EMAIL:-infoatats@gmail.com  
 OFF-011-35559249, MOB-9910315171

**CONSULTANT**

\_\_\_\_\_

**CONSULTANT**

\_\_\_\_\_

**RELEASE FOR**

INFORMATION	TENDER	CONSTRUCTION	AS BUILT
-------------	--------	--------------	----------


**TITLE**  
 COORDINATED LAYOUT

DATE	04/10/2023
SCALE	1:25
DRAWN BY	VEDPAL
CHECKED BY	RR.
PRINTED BY	_____
DWG. NO.	IA-118

**COORDINATED LAYOUT**

NOTES:-

- 1) ALL ELCB USED WILL BE OF 30 mA RATING ONLY.
- 2) ALL CONDUITS USED WILL BE MS CONDUITS ONLY.
- 3) ALL WIRES AND CABLES WILL BE CU FRLS WIRES & CABLES ONLY.
- 4) ALL POWER SOCKETS WILL BE WITH SHUTTER MECHANISM.
- 5) EXIT LIGHTS BE PROVIDED & SUPPLIED THROUGH UPS CIRCUIT.
- 6) EMERGENCY & EXIT LIGHTS SHOULD BE WIRED WITH FIRE RATED CABLE.
- 7) ALL SINGLE -PHASE WIRING SHALL BE WITH FRLC PVC INSULATED WIRES HAVING PHASE, NEUTRAL AND EARTH.
- 8) SINGNAGE ,FA PANEL ,CASH COUNTER ,OTHER CRITICAL EQUIPMENT SHALL BE LOOPED ON UPS CIRCUITS
- 9) 2\*6 SQ MM CU WIREL +2\*5 SQMM EARTH WIRE.FRLS PVC INSULATED CABLE.

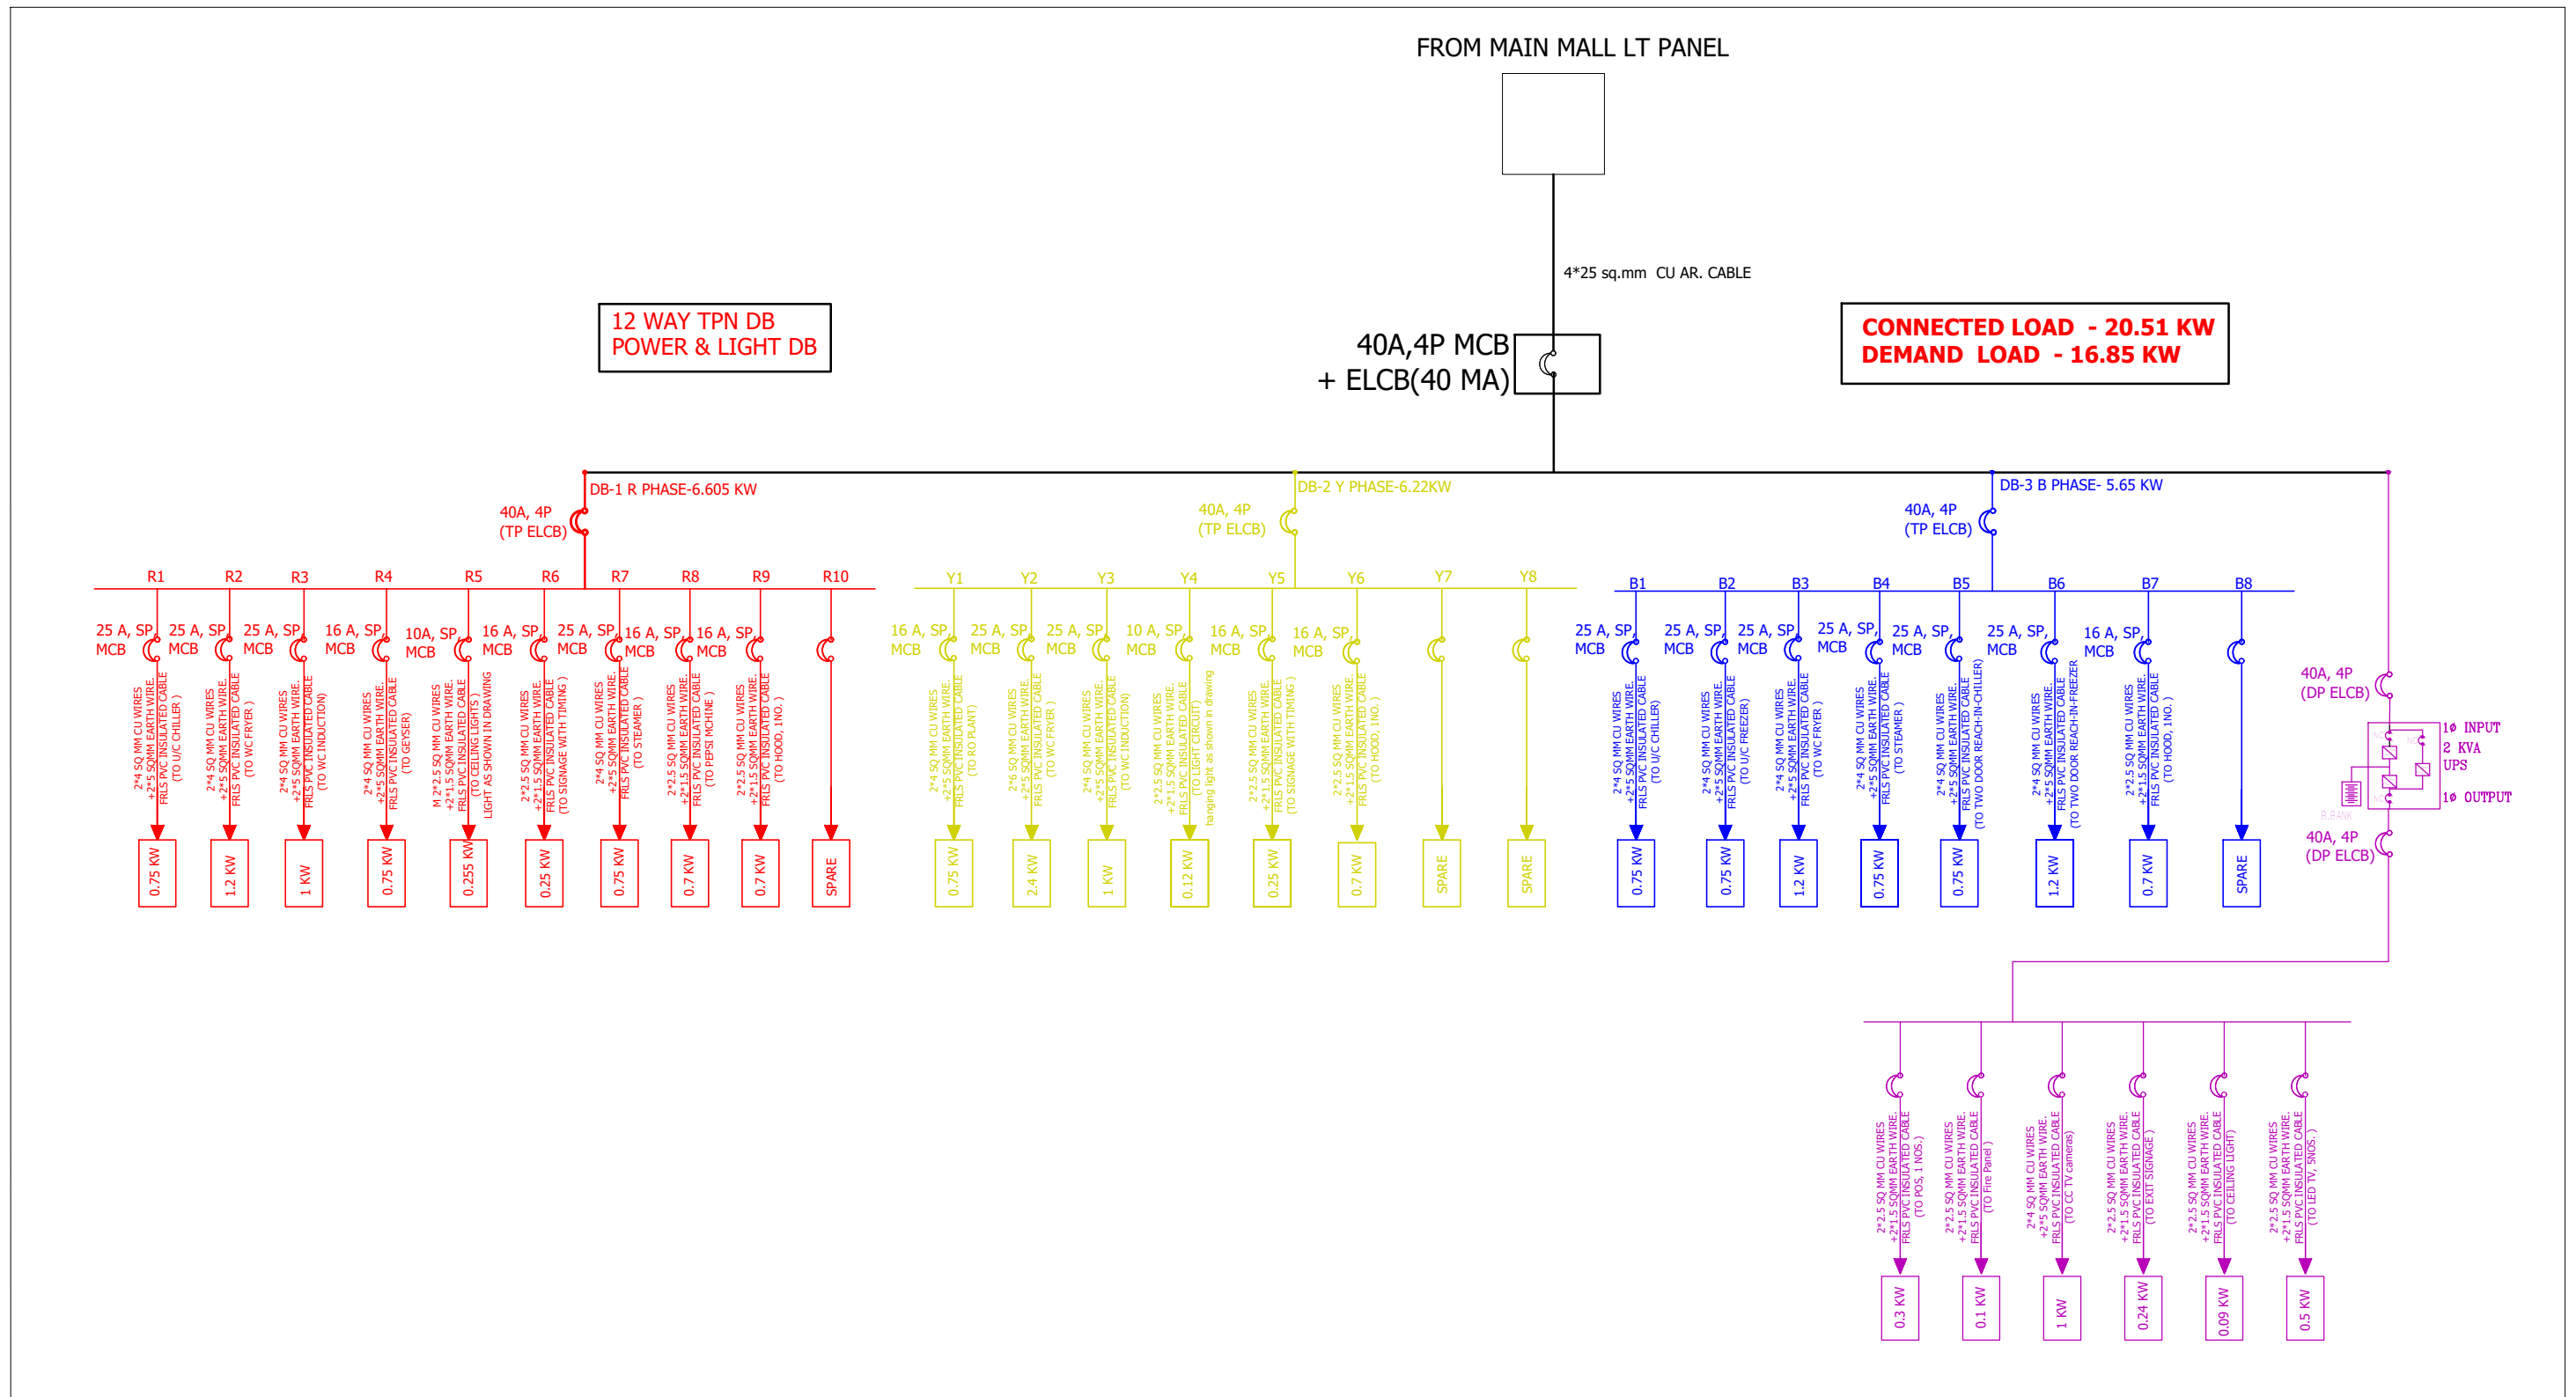

<b>PROJECT</b> WOW MOMO & WOW CHINA @ AHMEDABAD AIRPORT FOOD COURT, GUJARAT.
<b>CLIENT</b> WOW MOMO & WOW CHINA

<b>NOTE:</b> THIS DRAWING & DESIGN IS THE COPYRIGHT OF THE DESIGNER. NO PORTION MAY BE REPRODUCED WITHOUT THE WRITTEN PERMISSION OF THE DESIGNERS
1. ALL DIMENSIONS ARE INCLUDING FINISHES
2. DO NOT SCALE DRAWING. ONLY MENTIONED DIMENSIONS ARE TO BE CONSIDERED.
3. ALL DIMENSIONS MUST BE CHECKED BEFORE COMMENCING WORK ON SITE.
4. ANY DISCREPANCIES SHALL BE BROUGHT UNDER THE NOTICE OF ARCHITECTS PRIOR COMMENCEMENT OF WORK.

REVISION		
S.NO.	REMARKS	DATE
1	REV 1	00/00/00
2	REV 2	00/00/00
3	REV 3	00/00/00
4	REV 4	00/00/00
5	REV 5	00/00/00
6	REV 6	00/00/00
7	REV 7	00/00/00
8	REV 8	00/00/00

**ARCHITECT / INTERIOR DESIGN**

OS ARCHITECTURE STUDIO  
Architecture Planning  
Interior Design  
FLAT NO-13 DDA SFS  
FLAT POCKET -1 SEC-6 DWARKA,  
NEW DELHI-110075  
EMAIL:-infoatats@gmail.com  
OFF-011-35559249, MOB:9910315171


<b>CONSULTANT</b> ..... .....
<b>CONSULTANT</b> ..... .....

RELEASE FOR			
INFORMATION	TENDER	CONSTRUCTION	AS BUILT

TITLE			
SINGLE LINE DIAGRAM ELECTRICAL SYSTEM (SLD)			
DATE	21/12/2023	CHECKED BY	RR
SCALE	N.T.S.	PRINTED BY	.....
DWG. NO.	IA-119A	DRAWN BY	VEDPAL

**LOAD CALCULATION FOR WOW MOMO & WOW CHINA @ AHMEDABAD AIRPORT FOOD COURT, GUJARAT.**

A										
<b>PLDB -12 W TPN DB</b>										
<b>INCOMING CABLE - 4 *25 SQ.MM AL AR CABLE</b>										
<b>INCOMING MCB -40 A TPN MCB</b>										
S.NO	EQUIPMENT DETAILS	CIRCUIT N.O(SP/DP/TP) (DB-1,2,3)	QTY	LOAD KW	TOTAL LOAD IN KW			TOTAL LOAD	MCB RATING	SOCKET TYPE
					R-PHASE	Y-PHASE	B-PHASE	KW		
1	RO PLANT	Y1 (SP)	1	0.75		0.75		0.75	16 A SP	16 A Sw socket ,6 Pin.
2	U/C CHILLER	R1, B1 (DP)	2	0.75	0.75		0.75	1.5	25 A DP	25 A IND socket ,3 Pin.
3	U/C FREEZER	B2 (SP)	1	0.75			0.75	0.75	25 A DP	25 A IND socket ,3 Pin.
4	FRYERS	R2, Y2, B3(TP)	4	1.2	1.2	2.4	1.2	4.8	25 A TP	25 A IND socket ,3 Pin.
5	INDUCTIONS	R3, Y3 (DP)	2	1	1	1		2	25 A DP	25 A IND socket 3 Pin
6	GEYSER	R4 (SP)	1	0.75	0.75			0.75	16 A SP	16 A Sw socket ,6 Pin.
7	CEILING LIGHT	R5(as shown in drawing)(SP)	17	0.015	0.255			0.255	10 A SP	N.A
8	HANGING LIGHT	Y4(as shown in drawing)(SP)	4	0.03		0.12		0.12	10 A SP	N.A
9	MAIN SIGNAGE	R6, Y5 (DP)	2	0.25	0.25	0.25		0.5	16 A DP	6/16 A socket
10	STEAMERS	R7, B4 (DP)	2	0.75	1		0.75	1.5	25 A DP	16 A Sw socket ,6 Pin.
11	TWO DOOR REACH-IN-CHILLER	B5 (SP)	1	0.75			0.75	0.75	25 A SP	25 A IND socket ,3 Pin.
12	TWO DOOR REACH-IN-FREEZER	B6 (SP)	1	0.75			0.75	0.75	25 A SP	25 A IND socket ,3 Pin.
13	PEPSI MACHINE	R8 (SP)	1	0.75	0.7			0.75	16 A SP	16 A Sw socket ,6 Pin.
14	HOODS	R9, Y6, B7(TP)	3	0.7	0.7	0.7	0.7	2.1	16 A TP	16 A Sw socket ,6 Pin.
15	UPS	Y7 (SP)	1	1		1		1	16 A SP	16 A Sw socket ,6 Pin.
<b>TOTAL</b>				<b>10.195</b>	<b>6.605</b>	<b>6.22</b>	<b>5.65</b>	<b>18.275</b>		
B										
<b>UPS DB (2.0 KVA UPS)</b>										
<b>UPS DB - 12 WAY SPN TYPE</b>										
<b>INCOMING CABLE - 2 * 2.5/4 SQ.MM Cu Cu wires + 1*5 Sqmm earth wire</b>										
<b>INCOMING MCB - 40 A TP ELCB</b>										
S.NO	EQUIPMENT DETAILS	CIRCUIT N.O	QTY	LOAD KW	TOTAL LOAD KW	MCB RATING				
1	POS		1	0.3	0.3	10 A SP				
2	Fire Panel		1	0.1	0.1	10 A SP				
3	CCTV Cameras		5	0.2	1	10 A SP				
4	EXIT SIGNAGE		2	0.12	0.24					
5	CEILING LIGHT	as shown in drawing	6	0.015	0.09	10 A SP				
6	LED TV	as shown in drawing	5	0.1	0.5	10 A SP				
<b>TOTAL</b>					<b>2.23</b>					
S.NO.	DESCRIPTION OF LOAD	CONNECTED LOAD IN KW	DIVERSITY FACTOR	DEMAND LOAD IN KW						
A	PDB	18.28	0.8	14.62						
B	UPSDB ( 2.0 KVA UPS )	2.23	1	2.23						
<b>TOTAL LOAD IN KW</b>		<b>20.51</b>		<b>16.85</b>						
<b>CONSIDER POWER FACTOR</b>		<b>0.7</b>		<b>0.7</b>						
<b>LOAD IN KVA</b>		<b>29.29</b>		<b>24.07</b>						

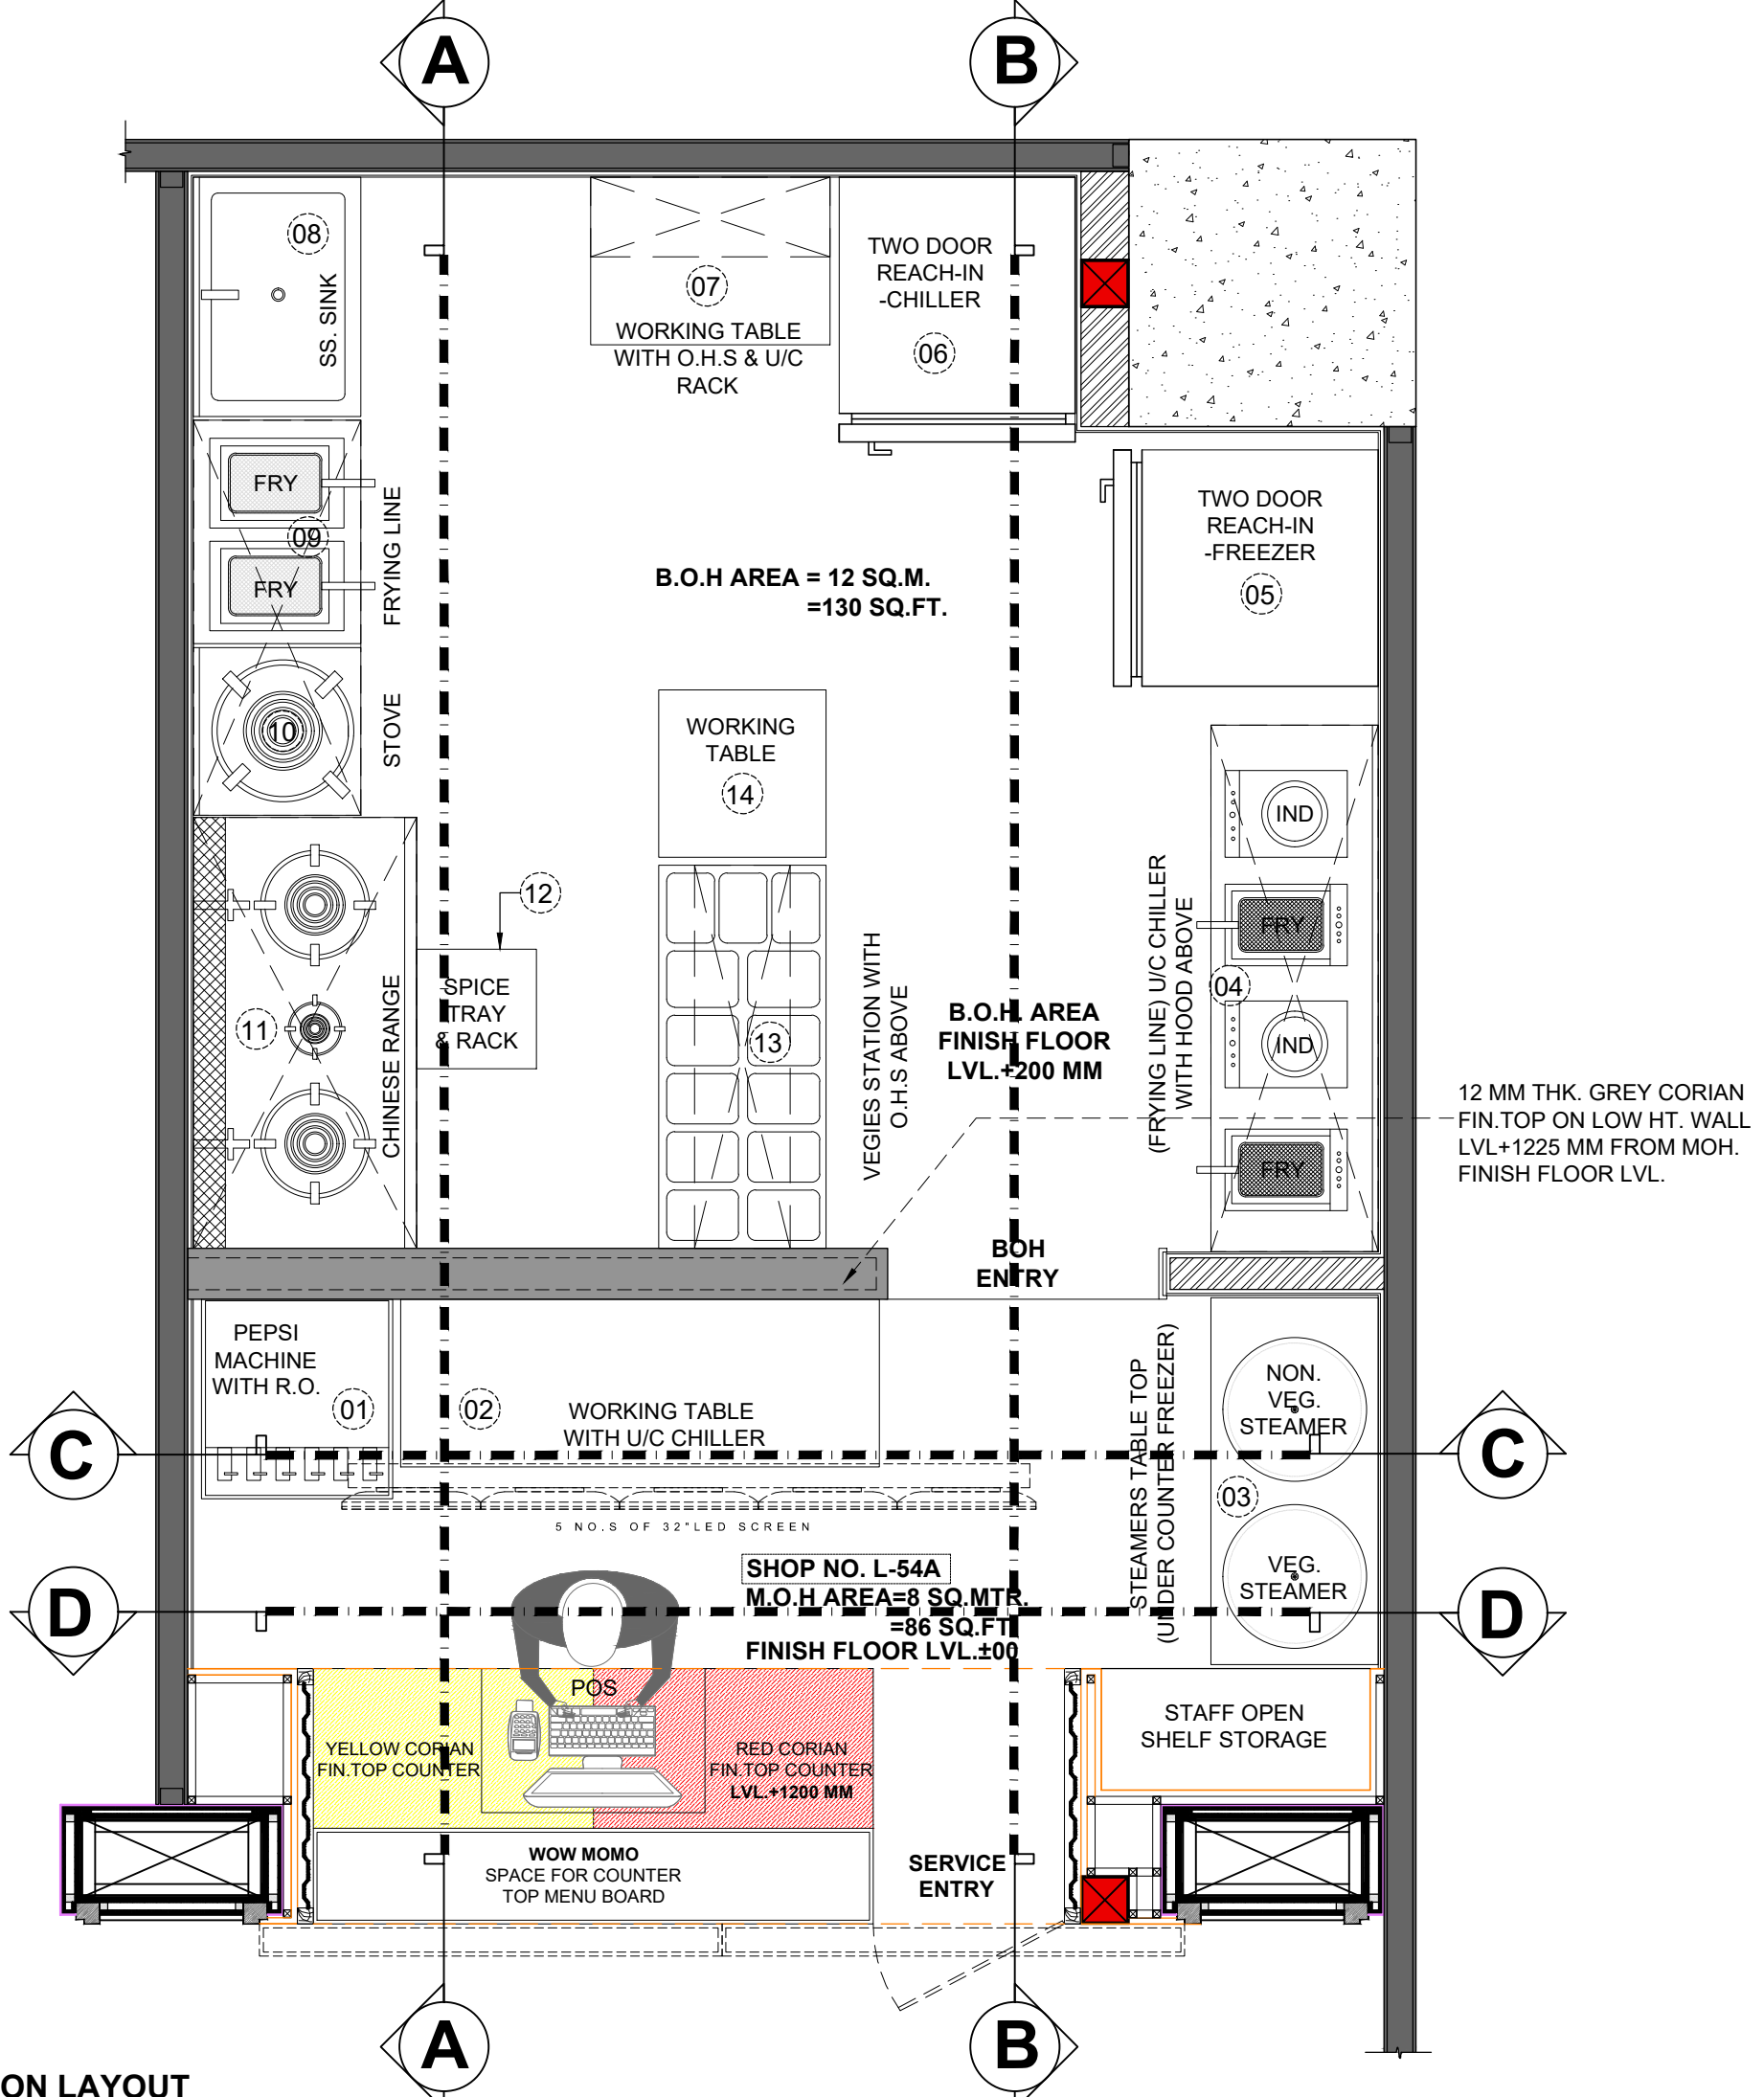

**SECTIONAL DEMARCATON LAYOUT**

**PROJECT**  
 WOW MOMO & WOW CHINA  
 @ AHMEDABAD AIRPORT  
 FOOD COURT, GUJARAT.

**CLIENT**  
 WOW MOMO & WOW CHINA


**NOTE:**  
 THIS DRAWING & DESIGN IS THE COPYRIGHT OF THE DESIGNER. NO PORTION MAY BE REPRODUCED WITHOUT THE WRITTEN PERMISSION OF THE DESIGNERS

1. ALL DIMENSIONS ARE INCLUDING FINISHES
2. DO NOT SCALE DRAWING ONLY MENTIONED DIMENSIONS ARE TO BE CONSIDERED.
3. ALL DIMENSIONS MUST BE CHECKED BEFORE COMMENCING WORK ON SITE.
4. ANY DISCREPANCIES SHALL BE BROUGHT UNDER THE NOTICE OF ARCHITECTS PRIOR COMMENCEMENT OF WORK.

**REVISION**

S.NO.	REMARKS	DATE
1	REV 1	
2	REV 2	
3	REV 3	
4	REV 4	
5	REV 5	
6	REV 6	
7	REV 7	
8	REV 8	

**ARCHITECT / INTERIOR DESIGN**



FLAT NO-13 DDA SFS  
 FLAT POCKET -1 SEC-6 DWARKA,  
 NEW DELHI-110075  
 EMAIL:-info@osdtd.com  
 OFF-011-35559249, MOB.9910315171

**CONSULTANT**

\_\_\_\_\_

**CONSULTANT**


\_\_\_\_\_

**RELEASE FOR**

INFORMATION	TENDER	CONSTRUCTION	AS BUILT

**TITLE**  
 SECTIONAL DEMARCATON LAYOUT

DATE	04/10/2023
SCALE	1:25
DRAWN BY	VEDPAL
CHECKED BY	RR.
PRINTED BY	_____
DWG. NO.	IA-200

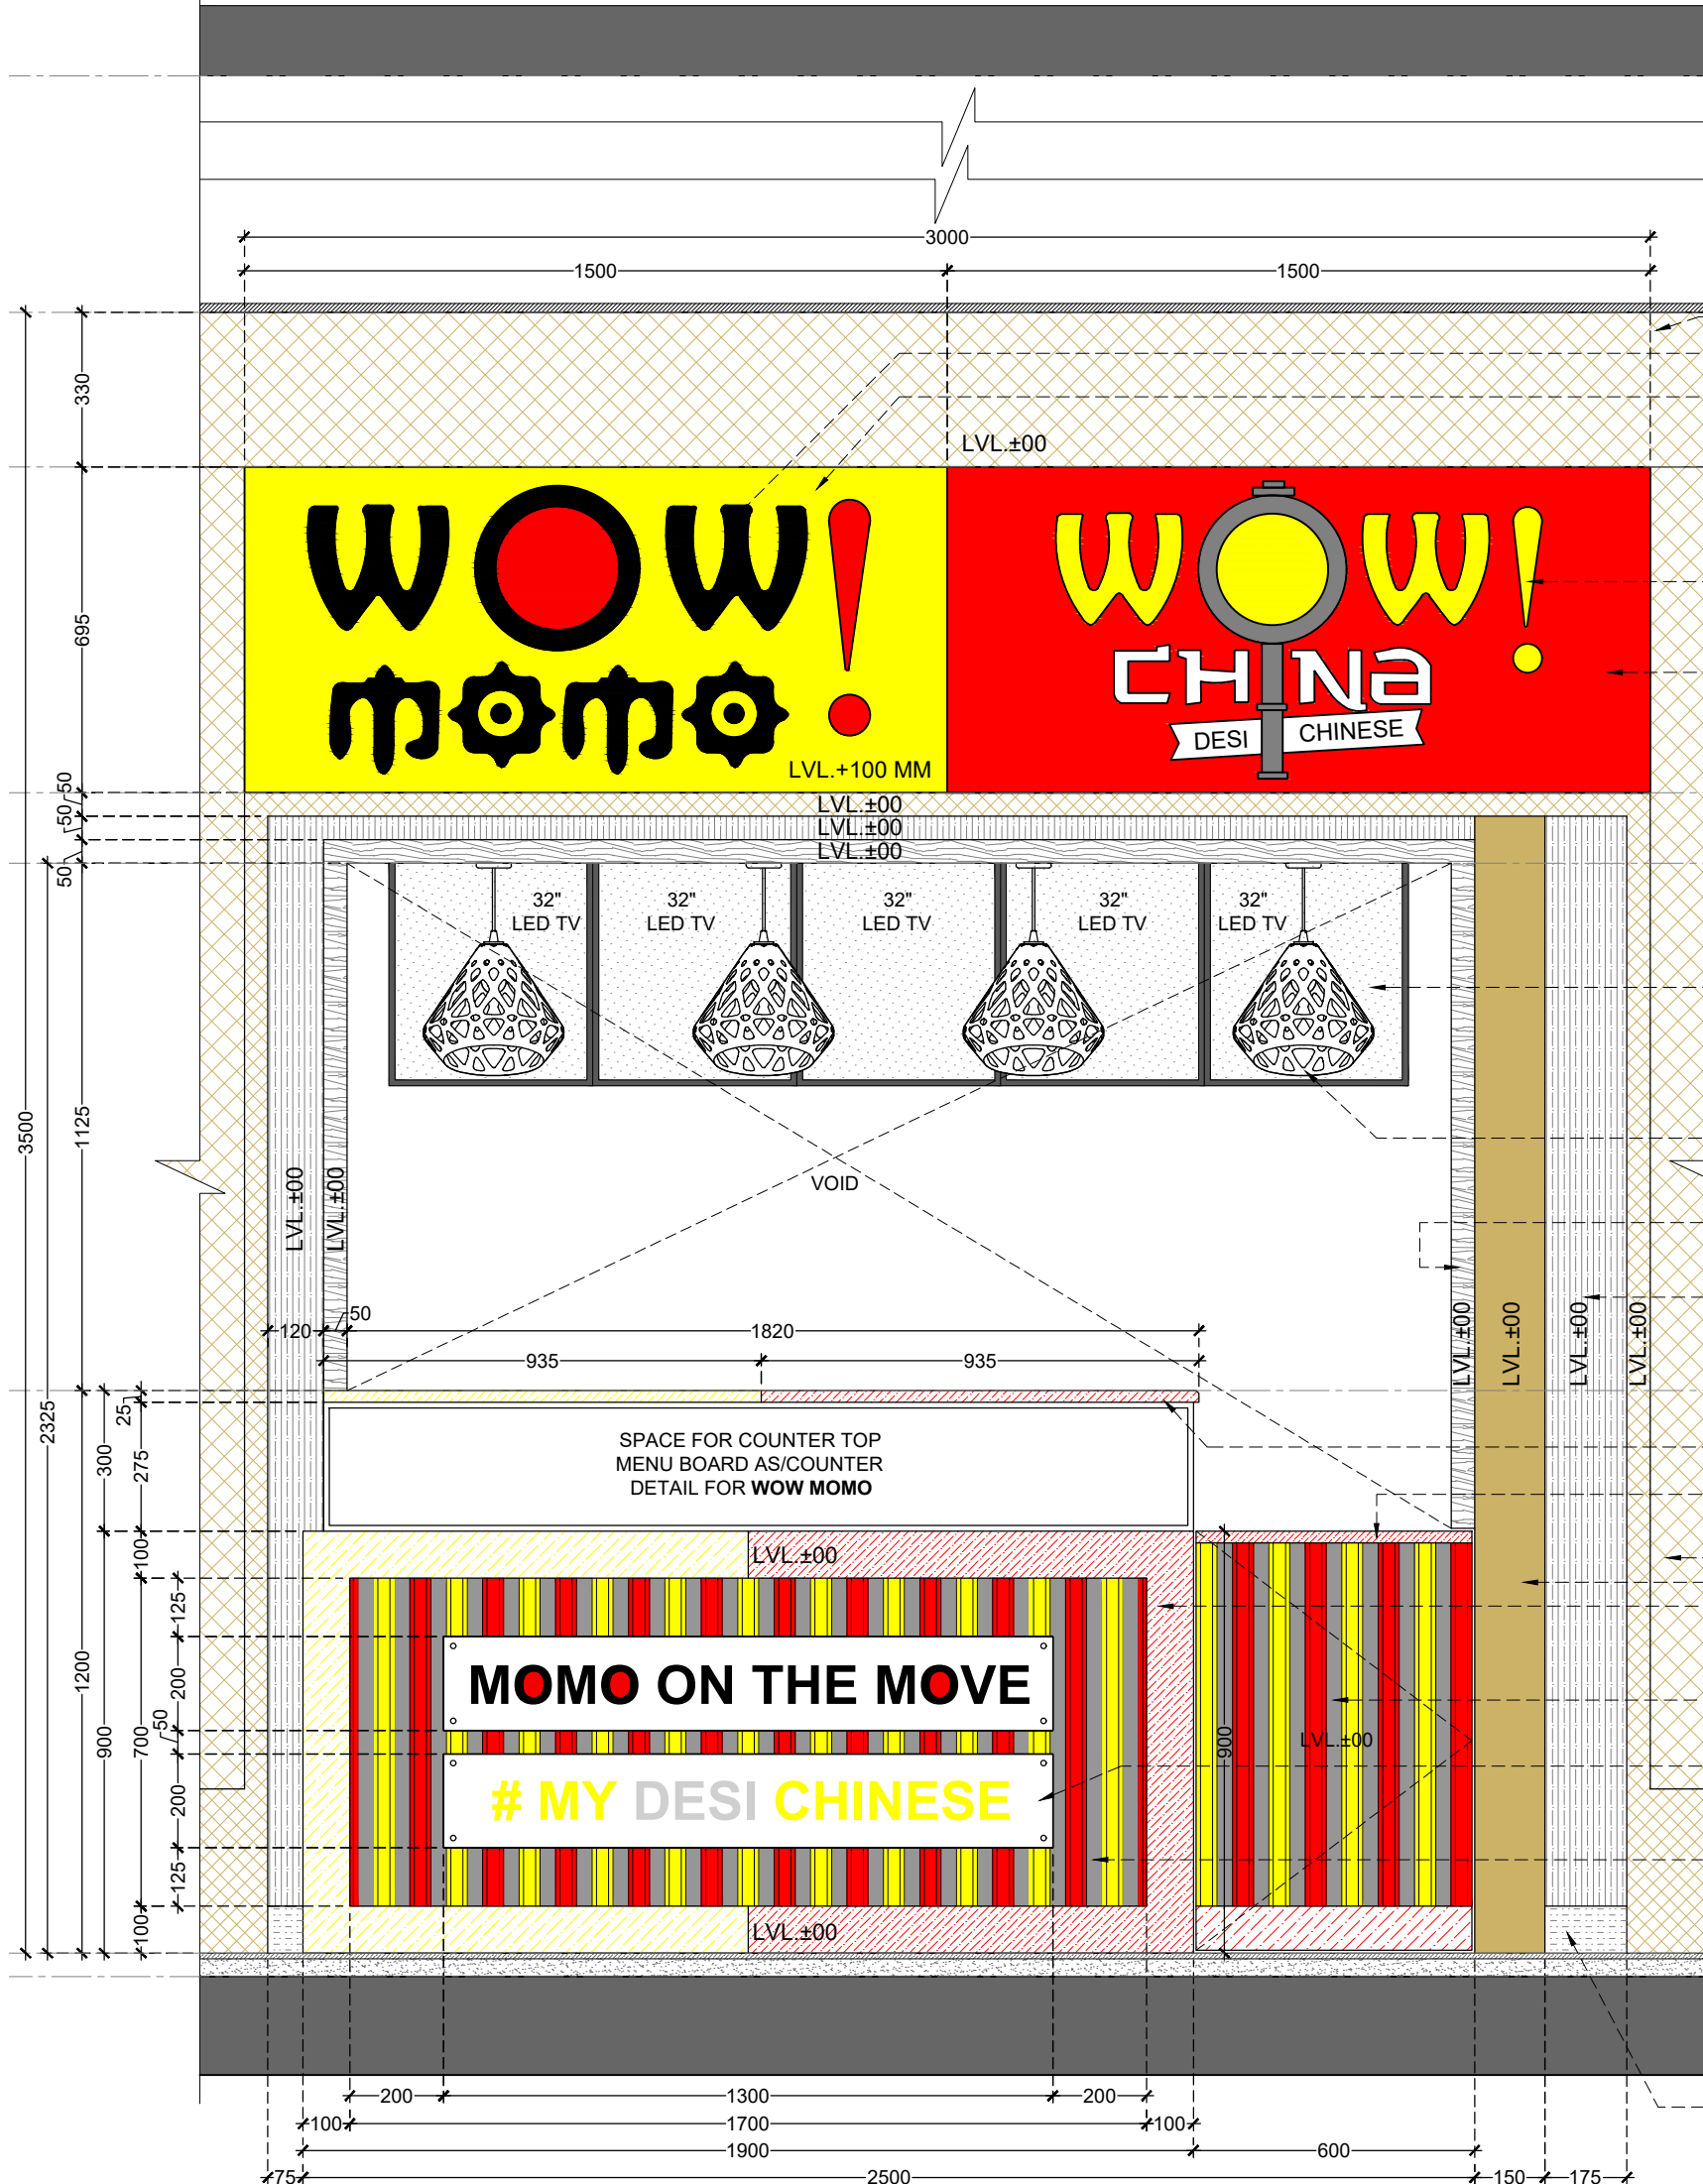

- BOTTOM OF SLAB  
LVL.+5550MM(FROM MOH. FFL.)
- MALL FALSE CEILING  
LVL.+3500MM(FROM MOH. FFL.)
- EXISTING MALL FINISH  
"WOW MOMO" BACKLIT RAISED CUT LETTER'S OVER BACKLIT BOX.  
YELLOW COLOUR ACRYLIC BACKLIT BOX
- TOP OF SIGNAGE  
LVL.+3170MM(FROM MOH. FFL.)
- "WOW CHINA" BACKLIT RAISED CUT LETTER'S OVER BACKLIT BOX.  
RED COLOUR ACRYLIC BACKLIT BOX
- BOTTOM OF SIGNAGE  
LVL.+2475MM(FROM MOH. FFL.)
- BOTTOM OF BULKHEAD  
LVL.+2325MM(FROM MOH. FFL.)
- "WOW CHINA MENU OVER LED TV
- HANGING LIGHT
- 50X50MM POLISHED SOLID WHITE OAK WOOD FRAME SURROUNDING  
14810WV-RH CHOMOIS TROPICAL MERINO LAMINATE VERTICAL GRAIN OVER 19 MM PLY OVER 25X25 MM FRAMEWORK
- TOP OF COUNTER  
LVL.+1200MM(FROM MOH. FFL.)
- 12 MM THK. RED CORIAN FIN. TOP OF COUNTER
- 12 MM THK. RED CORIAN FIN. TOP OF FLAP DOOR
- EXISTING MALL FINISH
- 100X100MM YELLOW & RED CORIAN BAND FINISH SURROUNDING OVER PLY BASE
- YELLOW, RED & GREY COLOR PAINTED CORRUGATED SHEET CLADDING OVER FLAP DOOR
- 12MM THK.TOUGHENED GLASS FIXED WITH SS SPACER & STUDS ABOVE COUNTER
- YELLOW, RED & GREY COLOR PAINTED CORRUGATED SHEET CLADDING OVER 19MM THK. PLY
- FLOOR FINISH LEVEL  
LVL.+50MM(FROM RAW SLAB)
- MALL RAW SLAB  
LVL.±00
- 100 MM HIGH SKIRTING MATCH SAME AS FLOORING

**PROJECT**  
WOW MOMO & WOW CHINA  
@ AHMEDABAD AIRPORT  
FOOD COURT, GUJARAT.

**CLIENT**  
WOW MOMO & WOW CHINA

**NOTE:**  
THIS DRAWING & DESIGN IS THE COPYRIGHT OF THE DESIGNER. NO PORTION MAY BE REPRODUCED WITHOUT THE WRITTEN PERMISSION OF THE DESIGNERS

1. ALL DIMENSIONS ARE INCLUDING FINISHES
2. DO NOT SCALE DRAWING ONLY MENTIONED DIMENSIONS ARE TO BE CONSIDERED.
3. ALL DIMENSIONS MUST BE CHECKED BEFORE COMMENCING WORK ON SITE.
4. ANY DISCREPANCIES SHALL BE BROUGHT UNDER THE NOTICE OF ARCHITECTS PRIOR COMMENCEMENT OF WORK.

**REVISION**

S.NO.	REMARKS	DATE
1	REV 1	.....
2	REV 2	
3	REV 3	
4	REV 4	
5	REV 5	
6	REV 6	
7	REV 7	
8	REV 8	

**ARCHITECT / INTERIOR DESIGN**

FLAT NO-13 DDA SFS  
FLAT POCKET -1 SEC-6 DWARKA,  
NEW DELHI-110075  
EMAIL:-info@os.in@gmail.com  
OFF-011-35559249, MOB:9910315171

**CONSULTANT**

.....

**CONSULTANT**

.....

**RELEASE FOR**


INFORMATION	TENDER	CONSTRUCTION	AS BUILT

**TITLE**  
FRONT ELEVATION

DATE	04/10/2023
SCALE	1:25
DRAWN BY	VEDPAL
CHECKED BY	RR.
PRINTED BY	.....
DWG. NO.	IA-201

**FRONT ELEVATION**



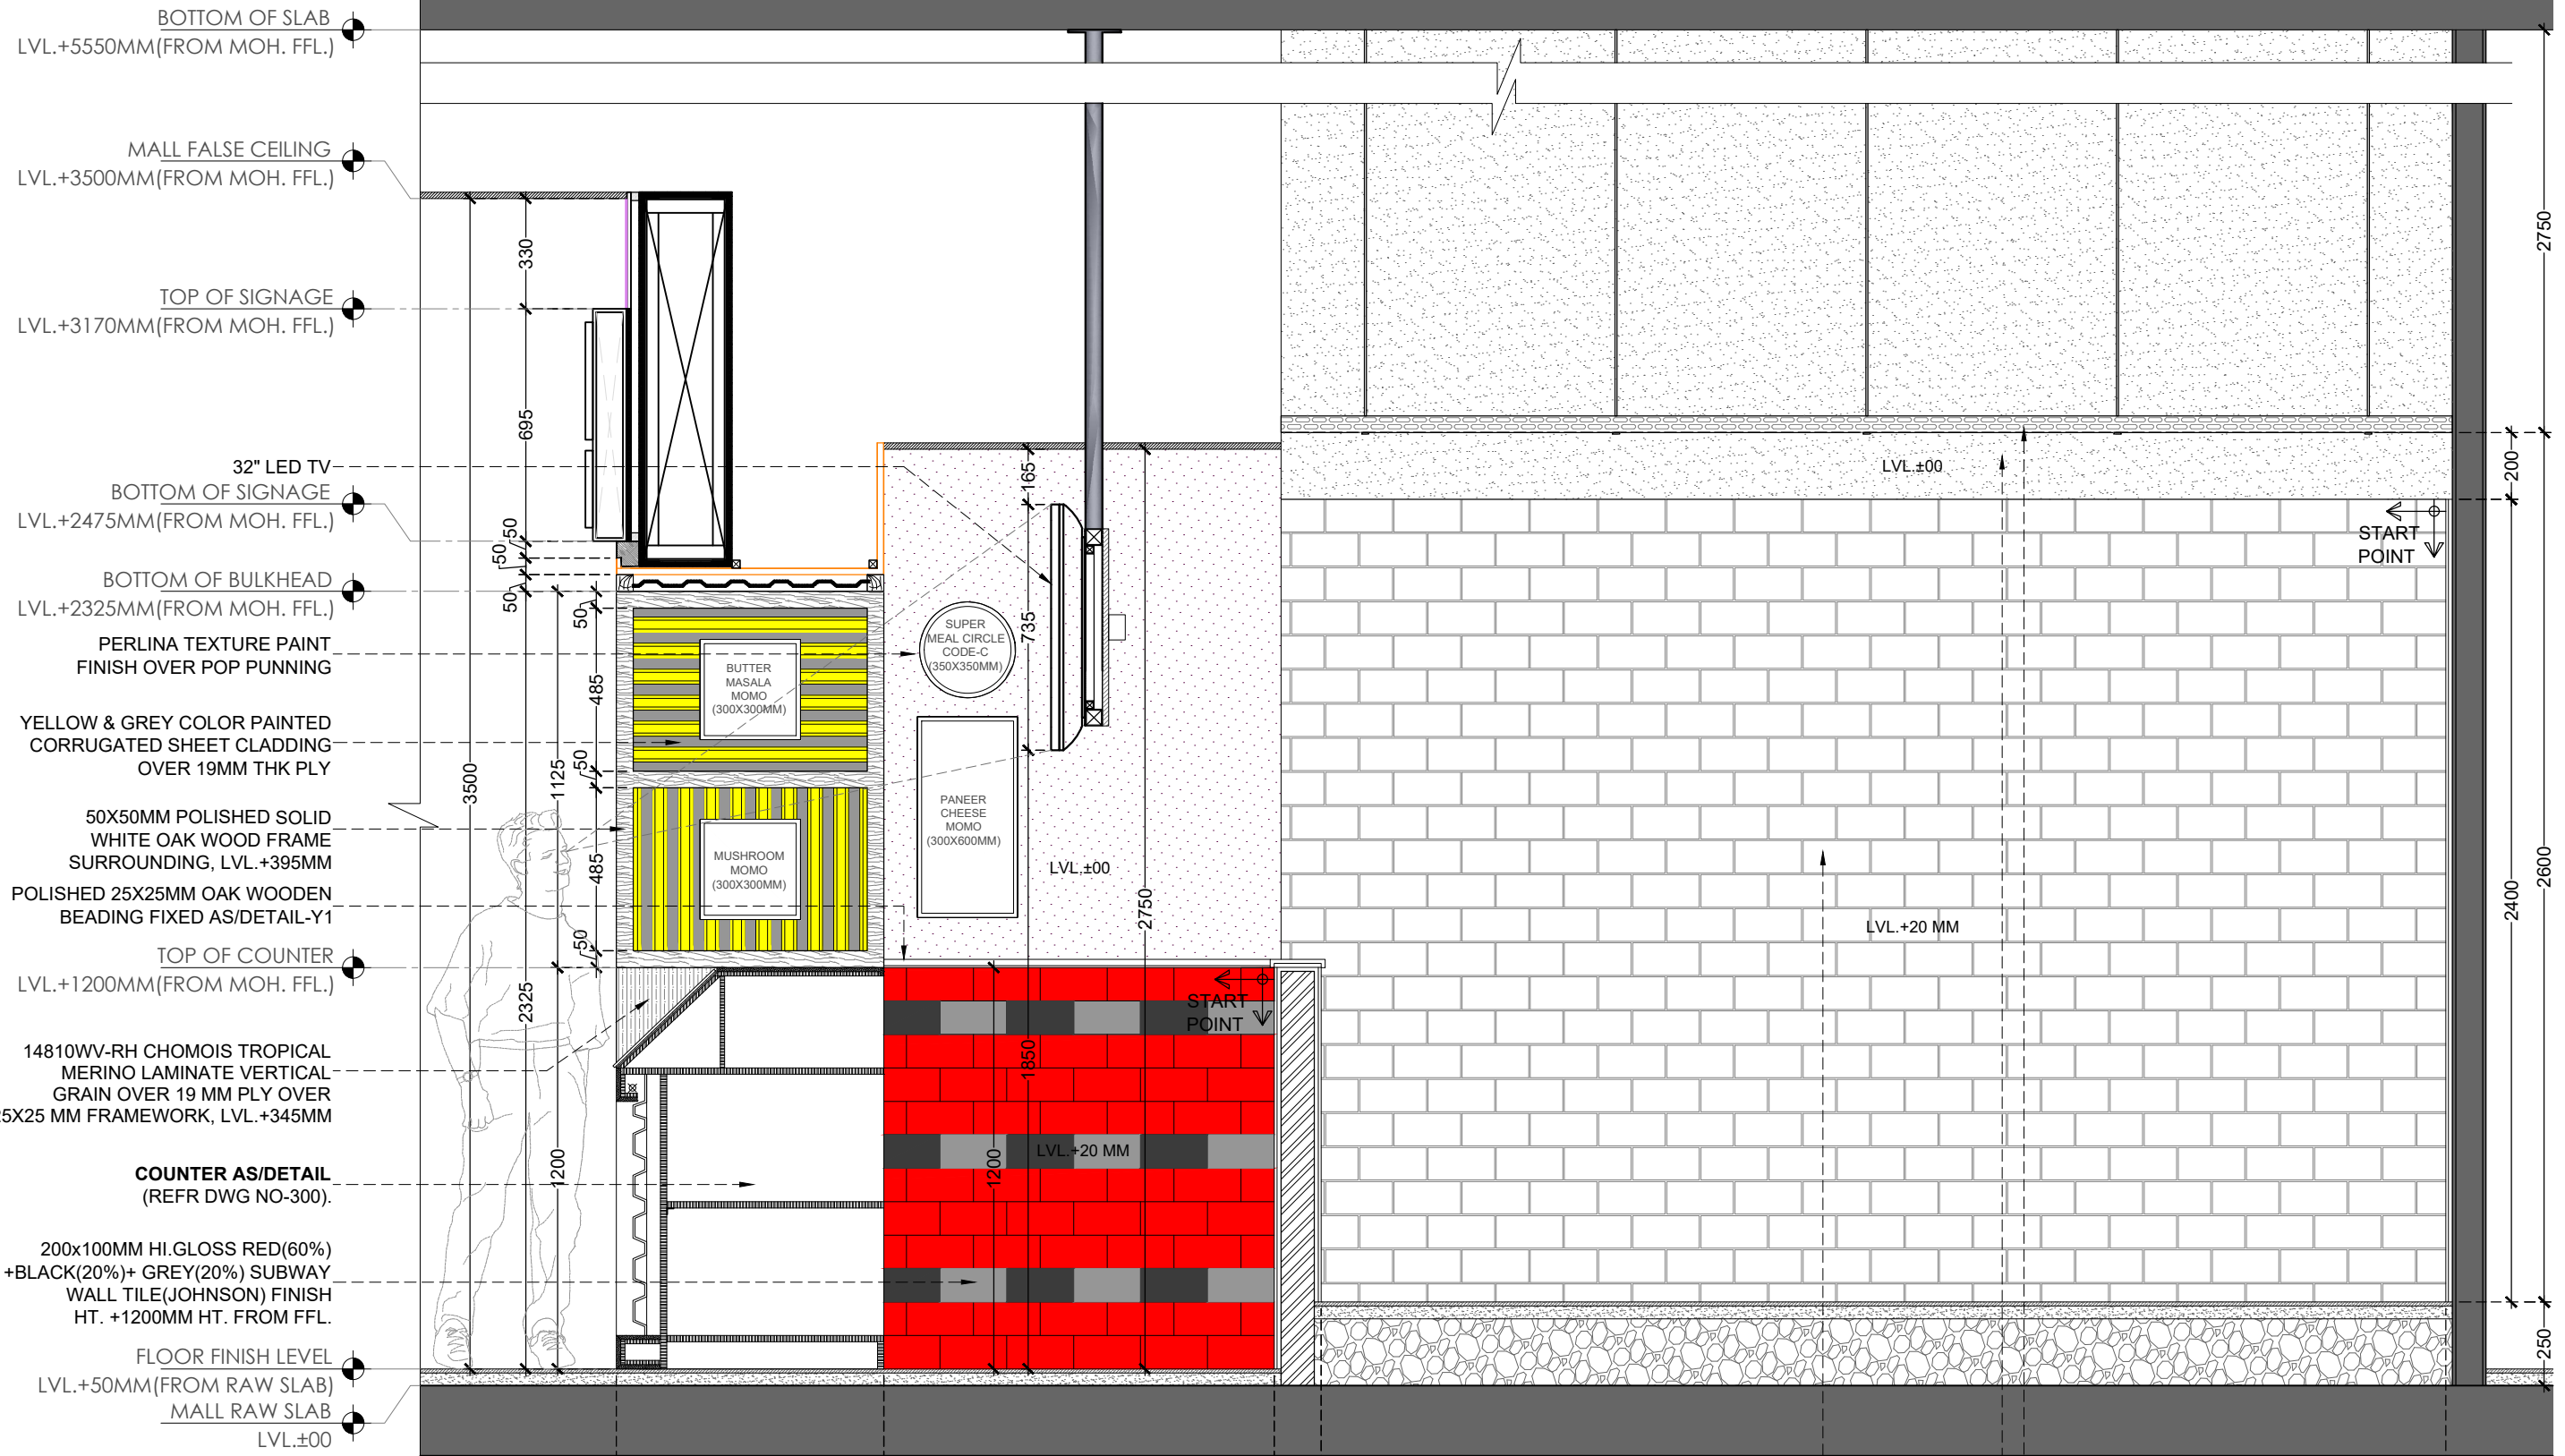

BOTTOM OF SLAB  
 LVL.+5550MM(FROM MOH. FFL.)

MALL FALSE CEILING  
 LVL.+3500MM(FROM MOH. FFL.)

TOP OF SIGNAGE  
 LVL.+3170MM(FROM MOH. FFL.)

32" LED TV  
 BOTTOM OF SIGNAGE  
 LVL.+2475MM(FROM MOH. FFL.)

BOTTOM OF BULKHEAD  
 LVL.+2325MM(FROM MOH. FFL.)

PERLINA TEXTURE PAINT  
 FINISH OVER POP PUNNING

YELLOW & GREY COLOR PAINTED  
 CORRUGATED SHEET CLADDING  
 OVER 19MM THK PLY

50X50MM POLISHED SOLID  
 WHITE OAK WOOD FRAME  
 SURROUNDING, LVL.+395MM

POLISHED 25X25MM OAK WOODEN  
 BEADING FIXED AS/DETAIL-Y1

TOP OF COUNTER  
 LVL.+1200MM(FROM MOH. FFL.)

14810WV-RH CHOMOIS TROPICAL  
 MERINO LAMINATE VERTICAL  
 GRAIN OVER 19 MM PLY OVER  
 25X25 MM FRAMEWORK, LVL.+345MM

**COUNTER AS/DETAIL**  
 (REFR DWG NO-300).

200x100MM HI.GLOSS RED(60%)  
 +BLACK(20%)+ GREY(20%) SUBWAY  
 WALL TILE(JOHNSON) FINISH  
 HT. +1200MM HT. FROM FFL.

FLOOR FINISH LEVEL  
 LVL.+50MM(FROM RAW SLAB)

MALL RAW SLAB  
 LVL.±00

**SECTIONAL ELEVATION-A**

WALL FINISHED WITH 200x100MM BLACK  
 HI-GLOSS SUBWAY TILE (MAKE: JOHNSON)  
 UPTO HT. +2400MM. FROM FFL.

150MM WIDE CABLE TRAY FINISHED WITH  
 OBSIDIAN GLASS 00NN 13/000 (MAKE-DULUX)  
 PAINT FINISH AT HT. +2600 FROM FFL.

OBSIDIAN GLASS 00NN 13/000  
 (MAKE-DULUX) PAINT FINISH

**PROJECT**  
 WOW MOMO & WOW CHINA  
 @ AHMEDABAD AIRPORT  
 FOOD COURT, GUJARAT.

**CLIENT**  
 WOW MOMO & WOW CHINA

**NOTE:**  
 THIS DRAWING & DESIGN IS THE COPYRIGHT OF THE DESIGNER. NO  
 PORTION MAY BE REPRODUCED WITHOUT THE WRITTEN PERMISSION OF  
 THE DESIGNERS

- ALL DIMENSIONS ARE INCLUDING FINISHES
- DO NOT SCALE DRAWING. ONLY MENTIONED DIMENSIONS ARE  
 TO BE CONSIDERED.
- ALL DIMENSIONS MUST BE CHECKED BEFORE COMMENCING  
 WORK ON SITE.
- ANY DISCREPANCIES SHALL BE BROUGHT UNDER THE NOTICE  
 OF ARCHITECTS PRIOR COMMENCEMENT OF WORK.

REVISION		
S.NO.	REMARKS	DATE
1	REV 1	00/00/00
2	REV 2	00/00/00
3	REV 3	00/00/00
4	REV 4	00/00/00
5	REV 5	00/00/00
6	REV 6	00/00/00
7	REV 7	00/00/00
8	REV 8	00/00/00

**ARCHITECT / INTERIOR DESIGN**


FLAT NO-13 DDA SFS  
 FLAT POCKET -1 SEC-6 DWARKA,  
 NEW DELHI-110075  
 EMAIL:-info@osstudio.com  
 OFF-011-40314174, MOB:9910315171

**CONSULTANT**  
 \_\_\_\_\_  
 \_\_\_\_\_  
**CONSULTANT**  
 \_\_\_\_\_  
 \_\_\_\_\_

**RELEASE FOR**

INFORMATION	TENDER	CONSTRUCTION	AS BUILT
-------------	--------	--------------	----------

TITLE			
SECTIONAL ELEVATION-A			
DATE	04/10/2023	CHECKED BY	RR
SCALE	NTS	PRINTED BY	_____
DWG. NO.	202A	DRAWN BY	VEDPAL

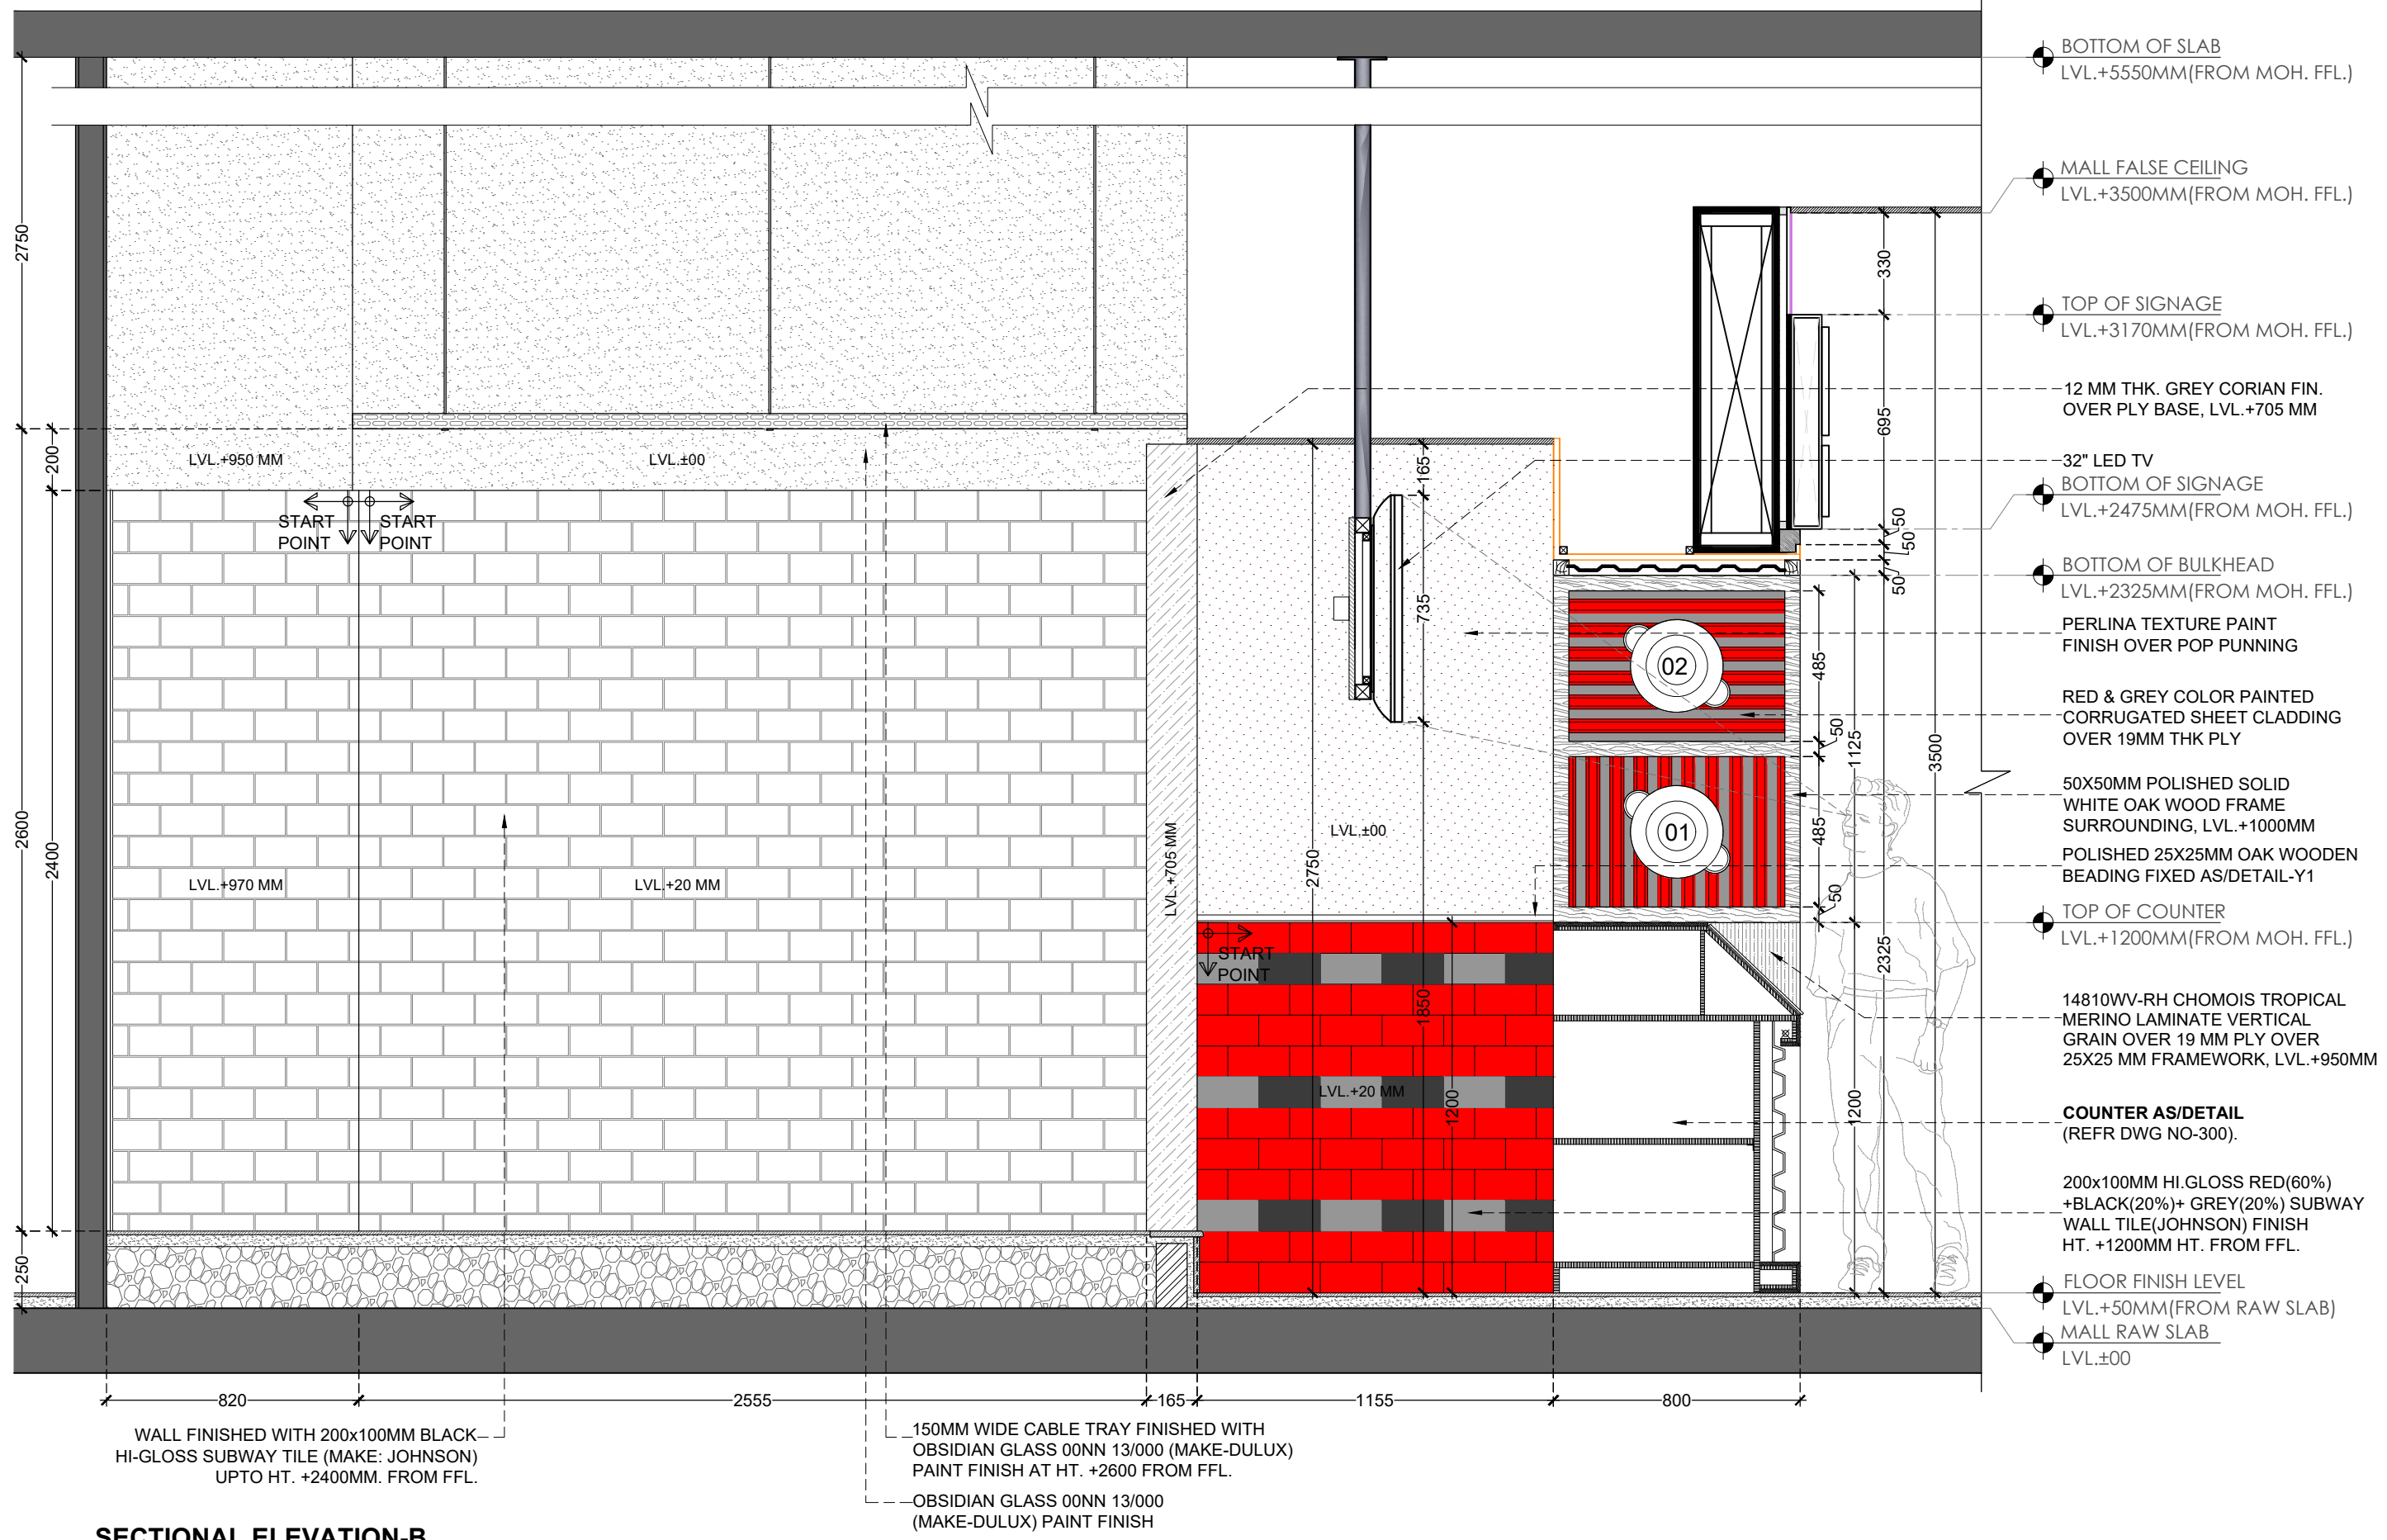

**SECTIONAL ELEVATION-B**

<b>PROJECT</b>
WOW MOMO & WOW CHINA @ AHMEDABAD AIRPORT FOOD COURT, GUJARAT.
<b>CLIENT</b>
WOW MOMO & WOW CHINA

<b>NOTE:</b>
THIS DRAWING & DESIGN IS THE COPYRIGHT OF THE DESIGNER. NO PORTION MAY BE REPRODUCED WITHOUT THE WRITTEN PERMISSION OF THE DESIGNERS
1. ALL DIMENSIONS ARE INCLUDING FINISHES
2. DO NOT SCALE DRAWING. ONLY MENTIONED DIMENSIONS ARE TO BE CONSIDERED.
3. ALL DIMENSIONS MUST BE CHECKED BEFORE COMMENCING WORK ON SITE.
4. ANY DISCREPANCIES SHALL BE BROUGHT UNDER THE NOTICE OF ARCHITECTS PRIOR COMMENCEMENT OF WORK.

<b>REVISION</b>		
S.NO.	REMARKS	DATE
1	REV 1	00/00/00
2	REV 2	00/00/00
3	REV 3	00/00/00
4	REV 4	00/00/00
5	REV 5	00/00/00
6	REV 6	00/00/00
7	REV 7	00/00/00
8	REV 8	00/00/00

**ARCHITECT / INTERIOR DESIGN**

FLAT NO-13 DDA SFS  
 FLAT POCKET -1 SEC-6 DWARKA,  
 NEW DELHI-110075  
 EMAIL:-infoatats@gmail.com  
 OFF-011-40314174, MOB:9910315171

<b>CONSULTANT</b>
_____
<b>CONSULTANT</b>
_____

<b>RELEASE FOR</b>
INFORMATION   TENDER   CONSTRUCTION   AS BUILT
_____

<b>TITLE</b>			
SECTIONAL ELEVATION-B			
DATE	04/10/2023	CHECKED BY	RR
SCALE	NTS	PRINTED BY	_____
DWG. NO.	202B	DRAWN BY	VEDPAL

**PROJECT**  
 WOW MOMO & WOW CHINA  
 @ AHMEDABAD AIRPORT  
 FOOD COURT, GUJARAT.

**CLIENT**  
 WOW MOMO & WOW CHINA


**NOTE:**  
 THIS DRAWING & DESIGN IS THE COPYRIGHT OF THE DESIGNER. NO PORTION MAY BE REPRODUCED WITHOUT THE WRITTEN PERMISSION OF THE DESIGNERS

1. ALL DIMENSIONS ARE INCLUDING FINISHES
2. DO NOT SCALE DRAWING ONLY MENTIONED DIMENSIONS ARE TO BE CONSIDERED.
3. ALL DIMENSIONS MUST BE CHECKED BEFORE COMMENCING WORK ON SITE.
4. ANY DISCREPANCIES SHALL BE BROUGHT UNDER THE NOTICE OF ARCHITECTS PRIOR COMMENCEMENT OF WORK.

**REVISION**

S.NO.	REMARKS	DATE
1	REV 1	.....
2	REV 2	
3	REV 3	
4	REV 4	
5	REV 5	
6	REV 6	
7	REV 7	
8	REV 8	

**ARCHITECT / INTERIOR DESIGN**



FLAT NO-13 DDA SFS  
 FLAT POCKET -1 SEC-6 DWARKA,  
 NEW DELHI-110075  
 EMAIL:-infoatats@gmail.com  
 OFF-011-35559249, MOB:9910315171

**CONSULTANT**  
 \_\_\_\_\_


**CONSULTANT**  
 \_\_\_\_\_

**RELEASE FOR**

INFORMATION	TENDER	CONSTRUCTION	AS BUILT

**TITLE**  
 SECTIONAL ELEVATION-C

DATE	04/10/2023
SCALE	1:25
DRAWN BY	VEDPAL
CHECKED BY	RR.
PRINTED BY	.....
DWG. NO.	IA-202C

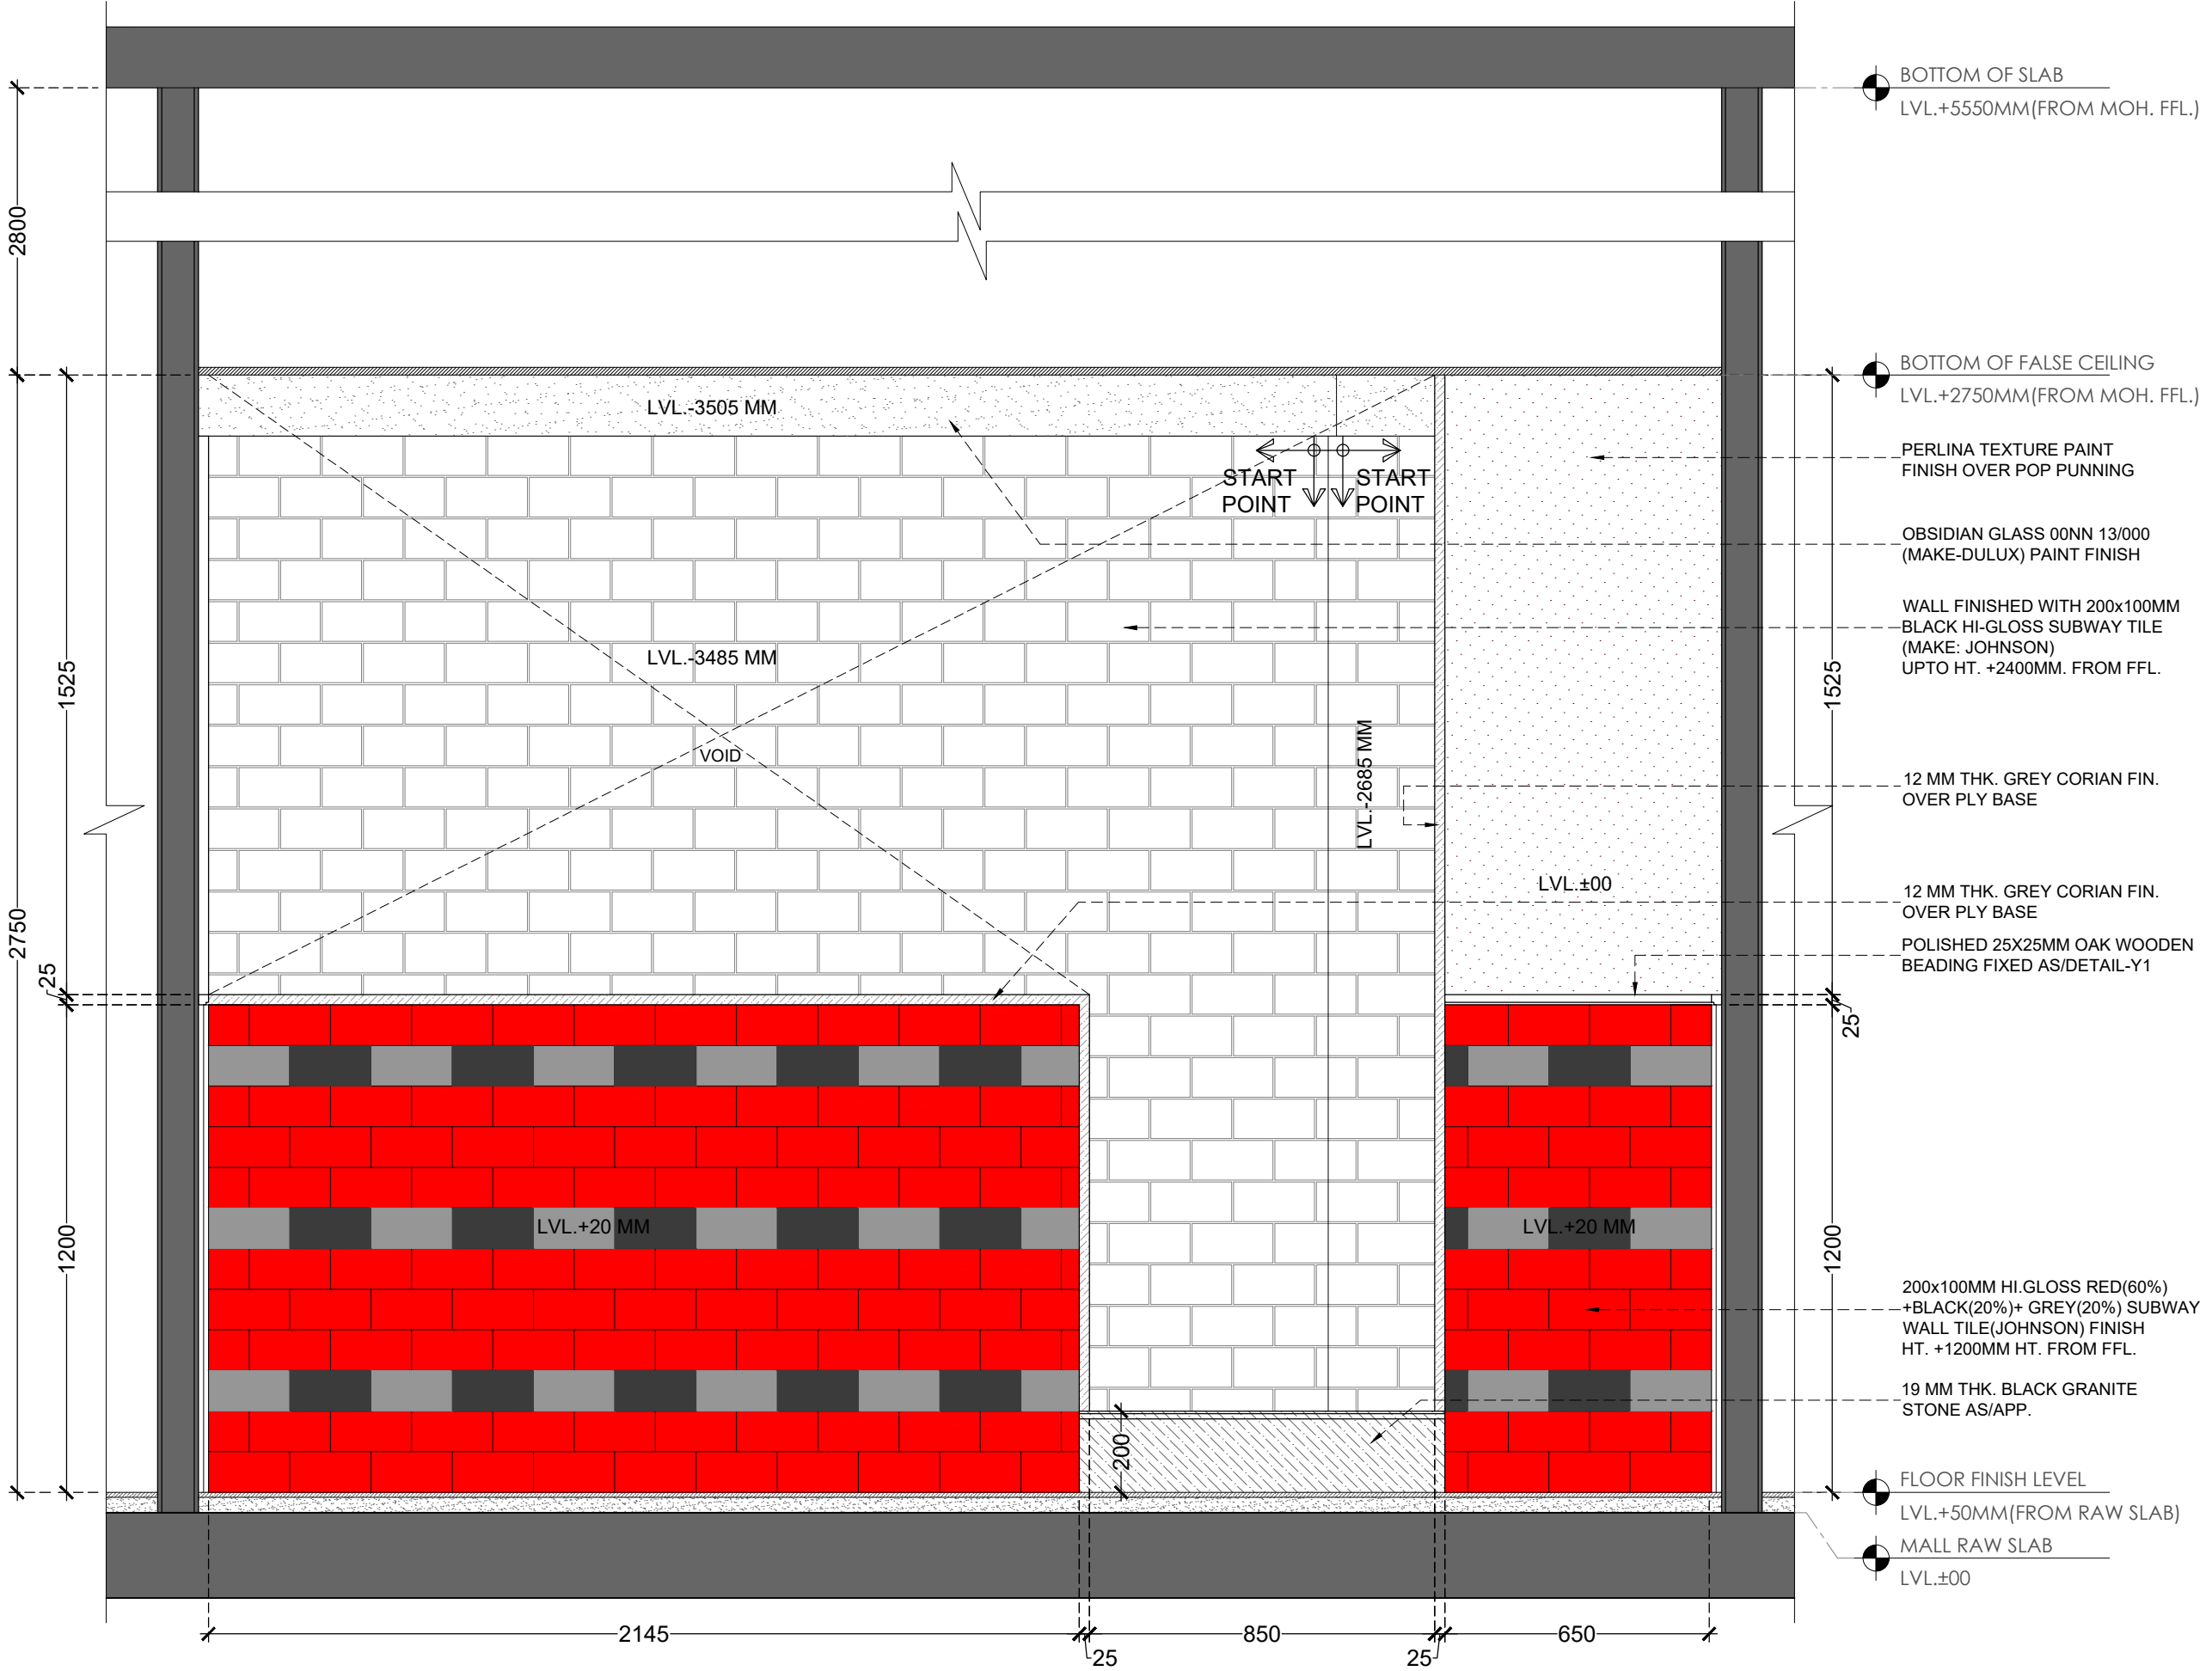

**SECTIONAL ELEVATION-C**

**NOTE:**  
THIS DRAWING & DESIGN IS THE COPYRIGHT OF THE DESIGNER. NO PORTION MAY BE REPRODUCED WITHOUT THE WRITTEN PERMISSION OF THE DESIGNERS  
1. ALL DIMENSIONS ARE INCLUDING FINISHES  
2. DO NOT SCALE DRAWING ONLY MENTIONED DIMENSIONS ARE TO BE CONSIDERED.  
3. ALL DIMENSIONS MUST BE CHECKED BEFORE COMMENCING WORK ON SITE.  
4. ANY DISCREPANCIES SHALL BE BROUGHT UNDER THE NOTICE OF ARCHITECTS PRIOR COMMENCEMENT OF WORK.

**REVISION**

S.NO.	REMARKS	DATE
1	REV 1	.....
2	REV 2	
3	REV 3	
4	REV 4	
5	REV 5	
6	REV 6	
7	REV 7	
8	REV 8	

**ARCHITECT / INTERIOR DESIGN**



FLAT NO-13 DDA SFS  
FLAT POCKET-1 SEC-6 DWARKA,  
NEW DELHI-110075  
EMAIL:-infoatats@gmail.com  
OFF-011-35559249, MOB-9910315171


**CONSULTANT**  
.....  
**CONSULTANT**  
.....

**RELEASE FOR**


INFORMATION	TENDER	CONSTRUCTION	AS BUILT
.....	.....	.....	.....

**TITLE**  
SECTIONAL ELEVATION-D


DATE	04/10/2023
SCALE	1:25
DRAWN BY	VEDPAL
CHECKED BY	RR.
PRINTED BY	.....
DWG. NO.	IA-202D

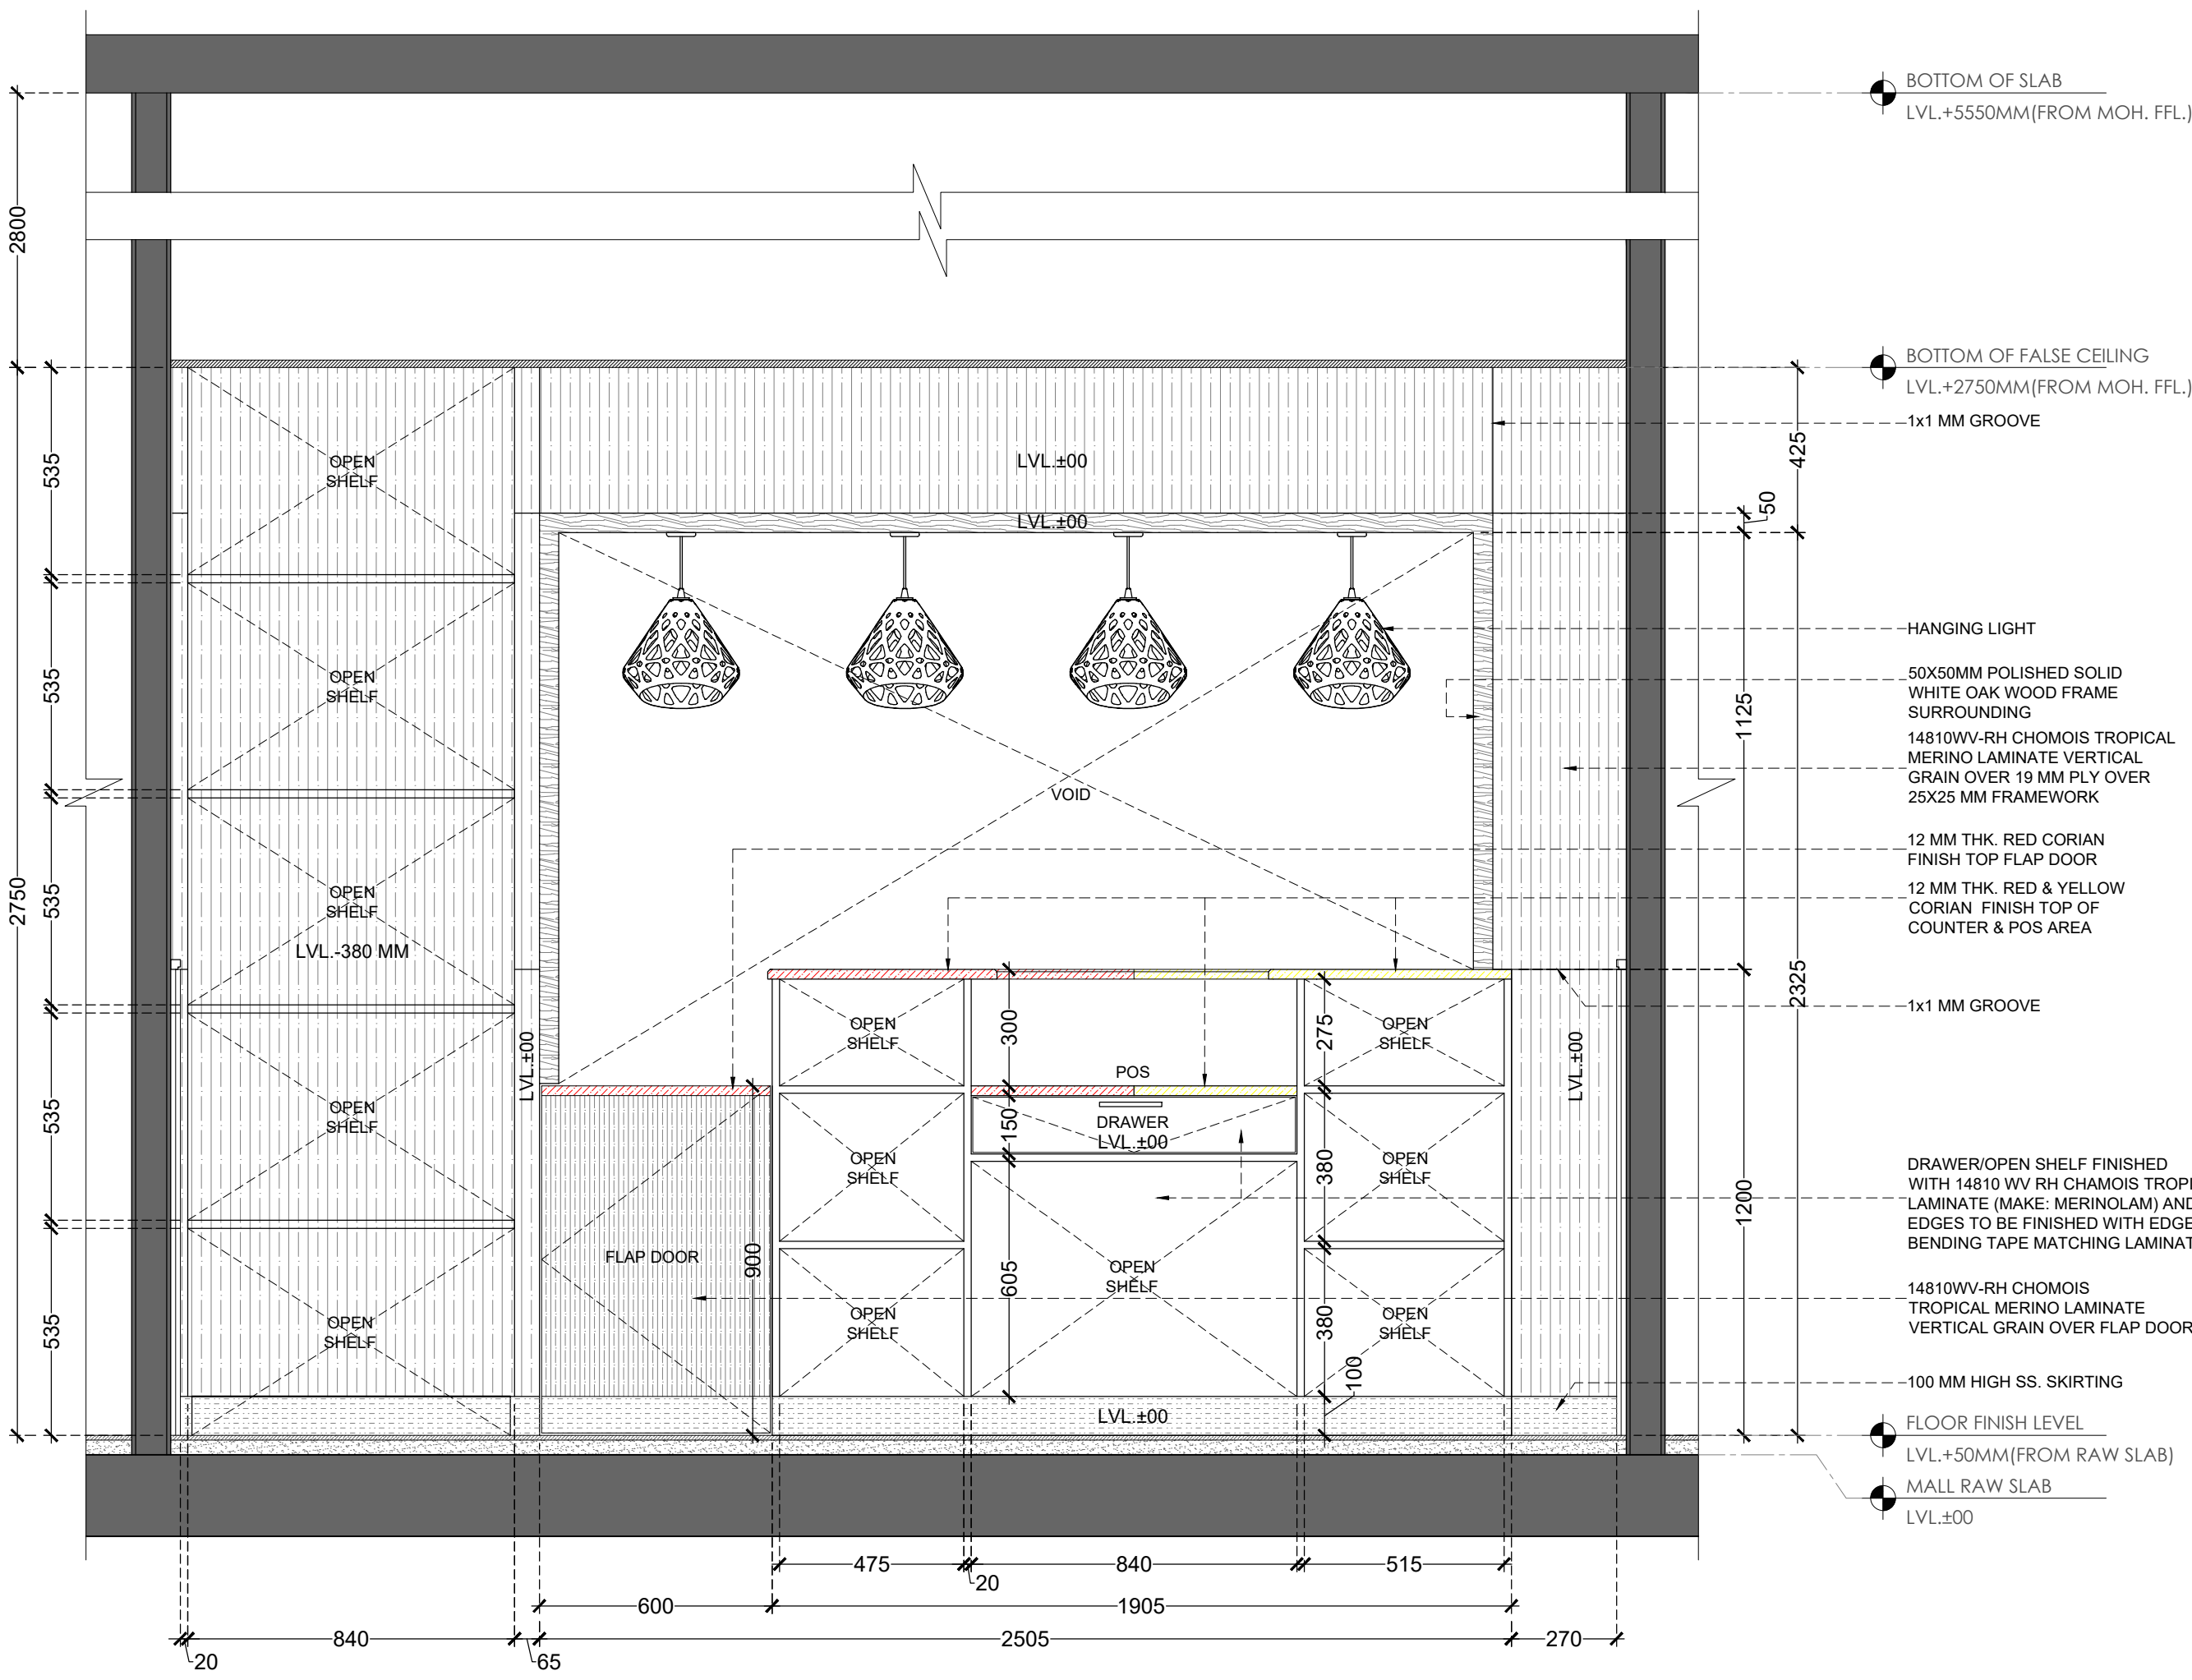

**SECTIONAL ELEVATION-D**

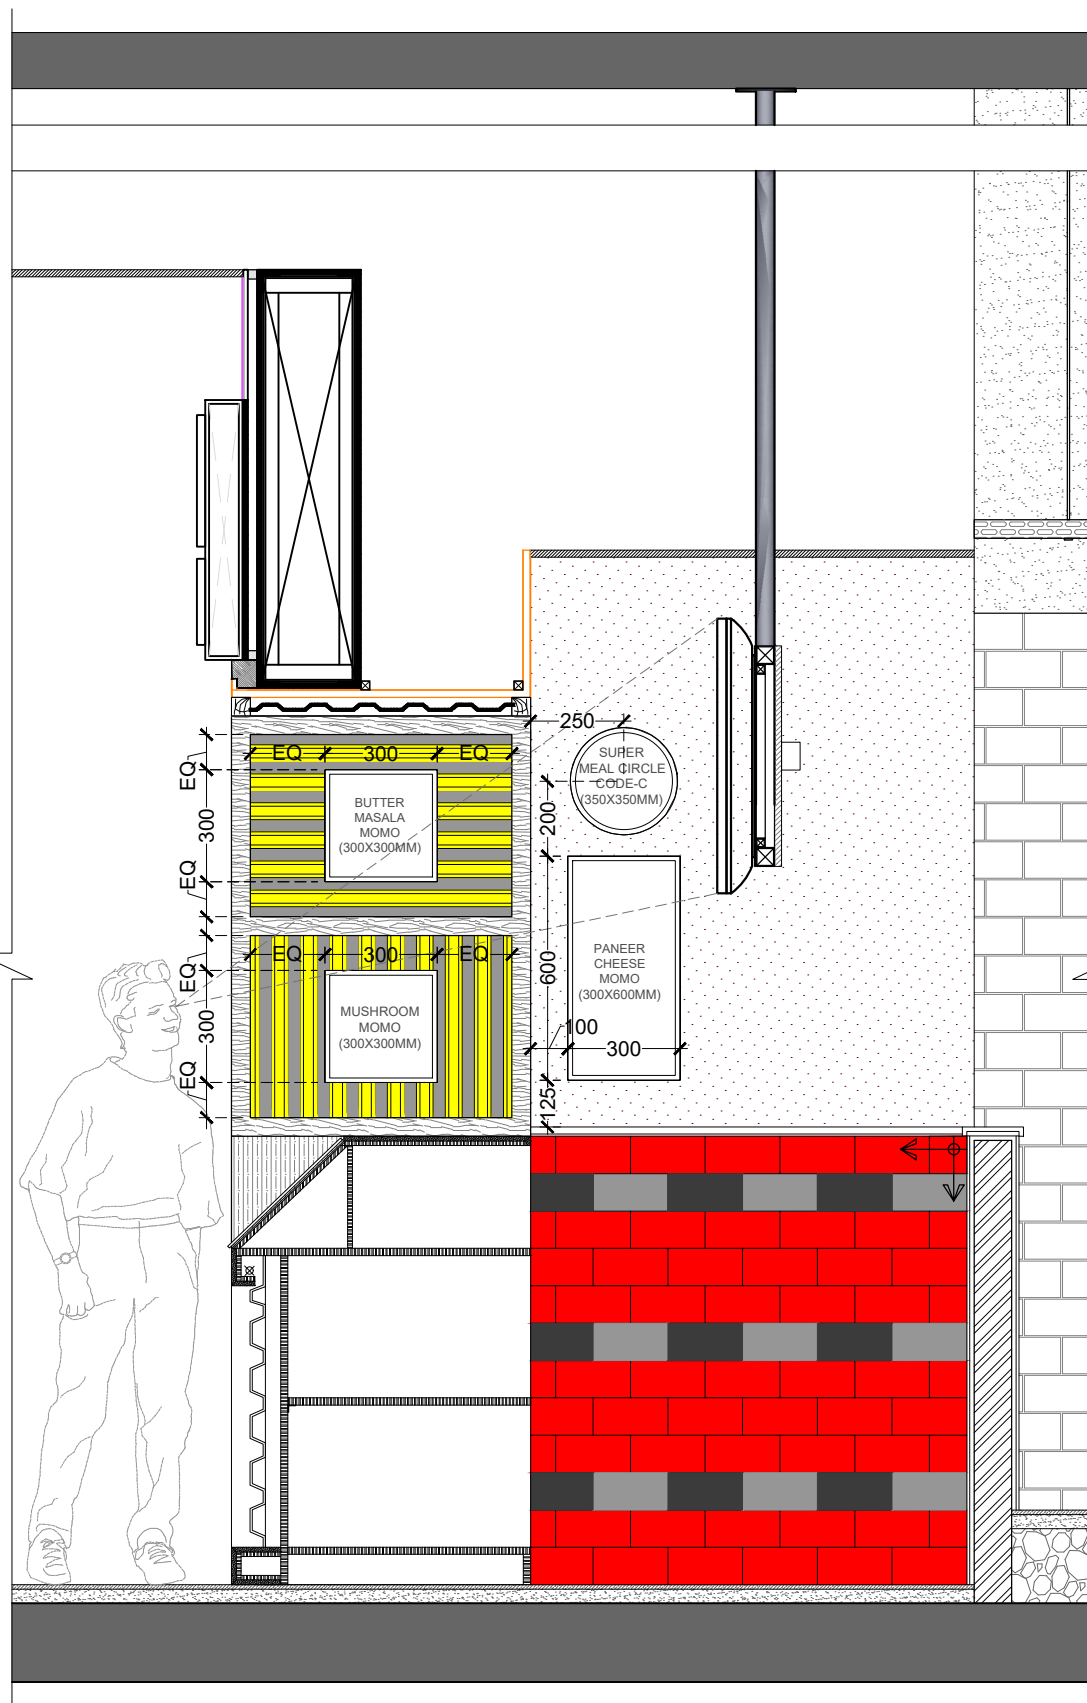

**BRANDING ELEVATION-A**

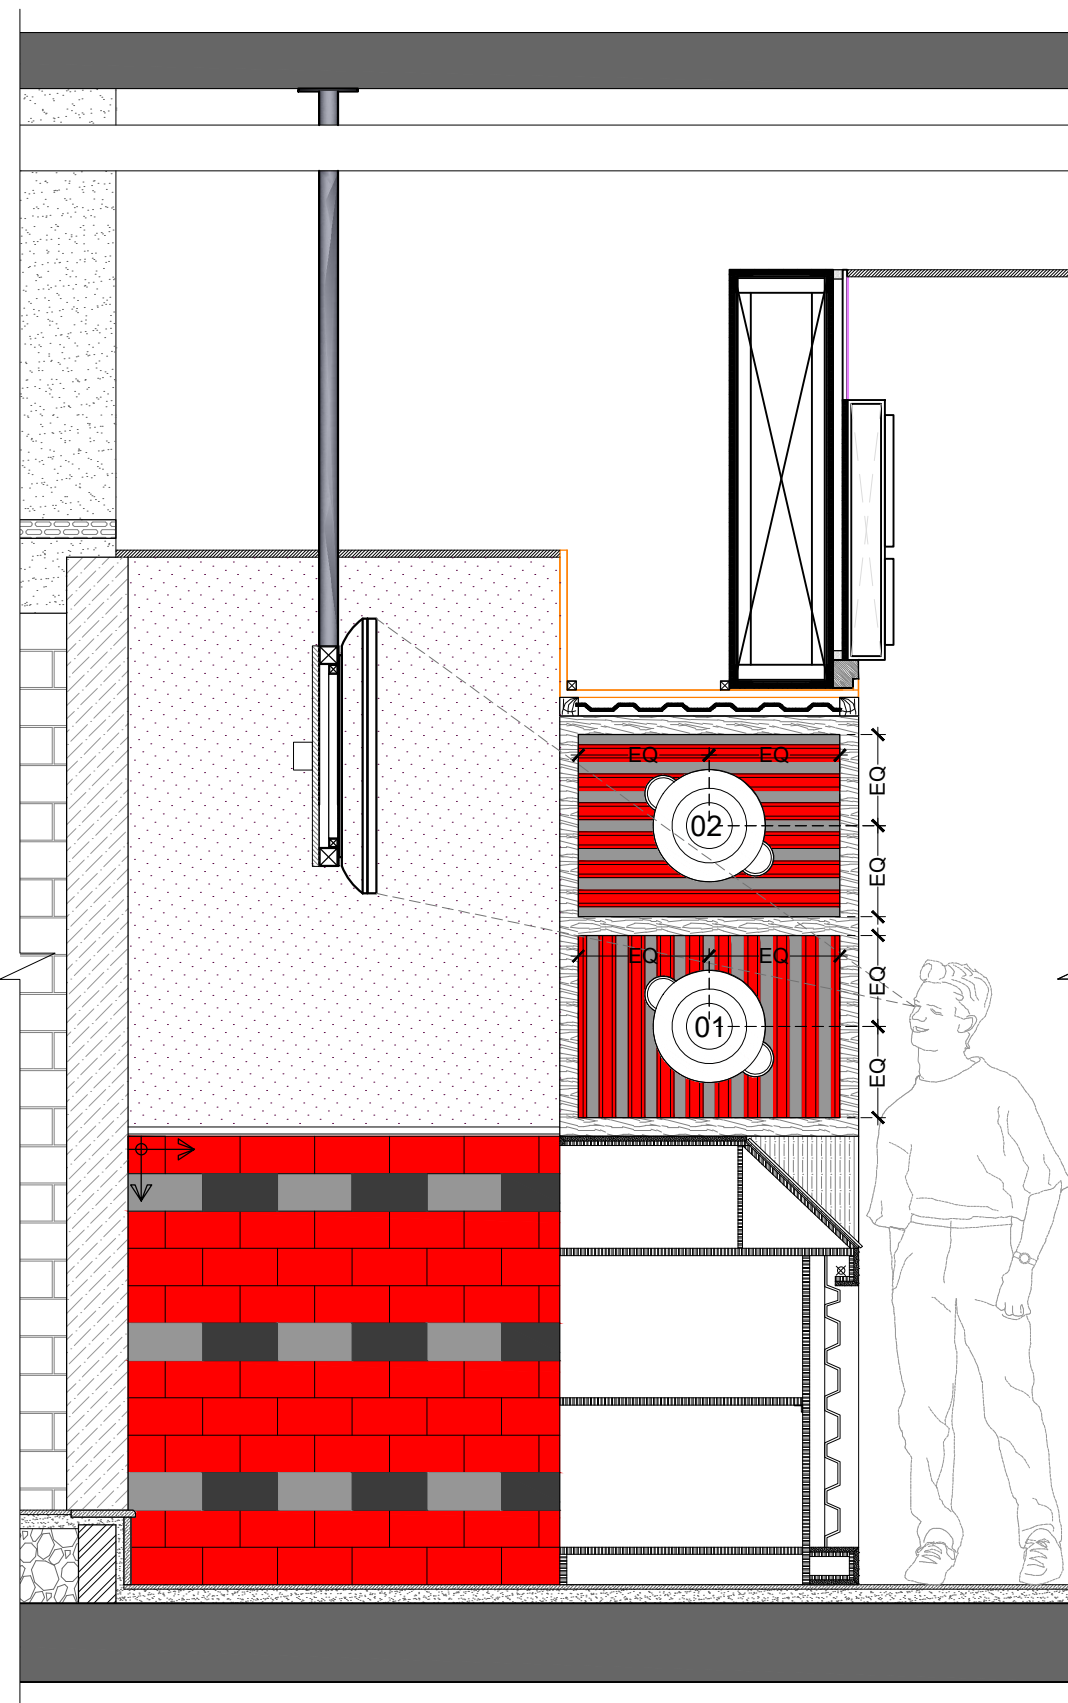

**BRANDING ELEVATION-B**

WOW CHINA BRANDING			
CODE	KADHAI	CODE	PAN
01	YELLOW KADHAYI(300MM Ø)	01A	YELLOW PAN(300MM Ø)
02	RED KADHAYI(300MM Ø)	02A	RED PAN(300MM Ø)
03	GREEN KADHAYI(300MM Ø)	03A	GREEN PAN(300MM Ø)
04	GREY KADHAYI(300MM Ø)	04A	BLCK PAN(300MM Ø)
05	ORANGE KADHAI(300MM Ø)	05A	ORANGE PAN(300MM Ø)

<b>PROJECT</b> WOW MOMO & WOW CHINA @ AHMEDABAD AIRPORT FOOD COURT, GUJARAT.
<b>CLIENT</b> WOW MOMO & WOW CHINA

<b>NOTE:</b> THIS DRAWING & DESIGN IS THE COPYRIGHT OF THE DESIGNER. NO PORTION MAY BE REPRODUCED WITHOUT THE WRITTEN PERMISSION OF THE DESIGNERS  1. ALL DIMENSIONS ARE INCLUDING FINISHES 2. DO NOT SCALE DRAWING. ONLY MENTIONED DIMENSIONS ARE TO BE CONSIDERED. 3. ALL DIMENSIONS MUST BE CHECKED BEFORE COMMENCING WORK ON SITE. 4. ANY DISCREPANCIES SHALL BE BROUGHT UNDER THE NOTICE OF ARCHITECTS PRIOR COMMENCEMENT OF WORK.
---

REVISION		
S.NO.	REMARKS	DATE
1	REV 1	00/00/00
2	REV 2	00/00/00
3	REV 3	00/00/00
4	REV 4	00/00/00
5	REV 5	00/00/00
6	REV 6	00/00/00
7	REV 7	00/00/00
8	REV 8	00/00/00

**ARCHITECT / INTERIOR DESIGN**

FLAT NO-13 DDA SFS  
FLAT POCKET -1 SEC-6 DWARKA,  
NEW DELHI-110075  
EMAIL:-info@osarchitects.com  
OFF-011-40314174, MOB:9910315171

<b>CONSULTANT</b> ----- -----
<b>CONSULTANT</b> ----- -----

RELEASE FOR			
INFORMATION	TENDER	CONSTRUCTION	AS BUILT

<b>TITLE</b> BRANDING ELEVATION- A & B			
DATE	04/10/2023	CHECKED BY	RR
SCALE	NTS	PRINTED BY	-----
DWG. NO.	203	DRAWN BY	VEDPAL

**PROJECT**

WOW MOMO @ AHMEDABAD AIRPORT  
FOOD COURT, GUJARAT.

**CLIENT**

WOW MOMO


**NOTE:**

THIS DRAWING & DESIGN IS THE COPYRIGHT OF THE DESIGNER. NO PORTION MAY BE REPRODUCED WITHOUT THE WRITTEN PERMISSION OF THE DESIGNERS

1. ALL DIMENSIONS ARE INCLUDING FINISHES
2. DO NOT SCALE DRAWING. ONLY MENTIONED DIMENSIONS ARE TO BE CONSIDERED.
3. ALL DIMENSIONS MUST BE CHECKED BEFORE COMMENCING WORK ON SITE.
4. ANY DISCREPANCIES SHALL BE BROUGHT UNDER THE NOTICE OF ARCHITECT'S PRIOR COMMENCEMENT OF WORK.

**REVISION**

S.NO.	REMARKS	DATE
1	REV 1	.....
2	REV 2	
3	REV 3	
4	REV 4	
5	REV 5	
6	REV 6	
7	REV 7	
8	REV 8	

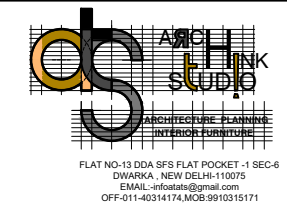

**CONSULTANT**

**CONSULTANT**

**RELEASE FOR**

INFORMATION	TENDER	CONSTRUCTION	ASBUILT
-------------	--------	--------------	---------

**TITLE**

BRANDING ELEVATION'S

DATE	04-10-2023
SCALE	NTS
DRAWN BY	VEDPAL
CHECKED BY	RR.
PRINTED BY	---
DWG. NO.	IA-203A



(20"X12")  
COUPLE



(12" X 12", 12"X24"&24"X12")  
BAKED MOMO AU GRATIN



(12" X 12", 12"X24"&24"X12")  
BUTTER MASALA MOMO



(12" X 12", 24"X12")  
CHEESE MOMO



(12" X 12", 12"X24"&24"X12")  
CHICKEN CHEESE MOMO




(12" X 12", 12"X24"&24"X12")  
CHOCOLATE MOMO




(12" X 12", 12"X24"&24"X12")  
CORN FRIED MOMO



GRAPHIC DESIGN

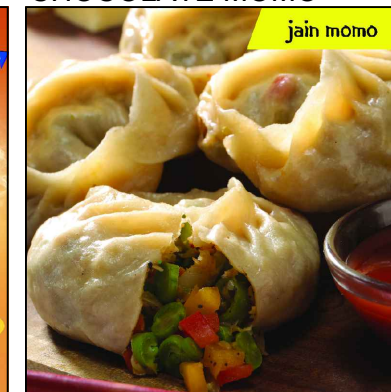

(12" X 12", 12"X24"&24"X12")  
JAIN MOMO

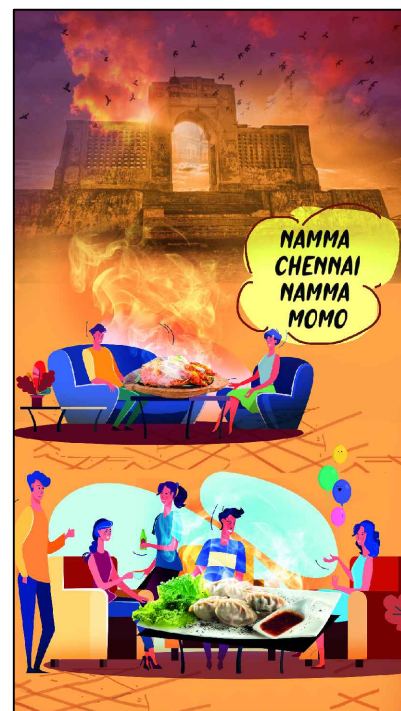

GRAPHIC DESIGN



(12" X 12", 12"X24"&24"X12")  
MOBURG



(12" X 12", 12"X24"&24"X12")  
CHOCOLATE SPRING ROLL



(15"X15")  
MOMO TIME



GRAPHIC DESIGN



(12" X 12", 12"X24"&24"X12")  
VEGGIE MOMO, WOK & WOK TOSSED SPRING ROLLS



Wok Tossed Spring Rolls



(12"X24"&24"X12")  
MUSHROOM MOMO



(12"X24"&24"X12")  
PAN FRIED MOMO



(12"X24"&24"X12")  
PANEER MOMO



(12"X24"&24"X12")  
RICE SIZZLER MOMO



(12"X24"&24"X12")  
SCHEZWAN MOMO



(12"X24"&24"X12")  
STEAMED MOMO



(12"X24"&24"X12")  
TANDOORI MOMO



(12"X24", 24"X12")  
THUKPA




(12"X24")  
MOMO REVOLUTION



MOBURG CIRCLE  
CODE -A(11"X11")



SIZZLER CIRCLE  
CODE-B(10"X10")

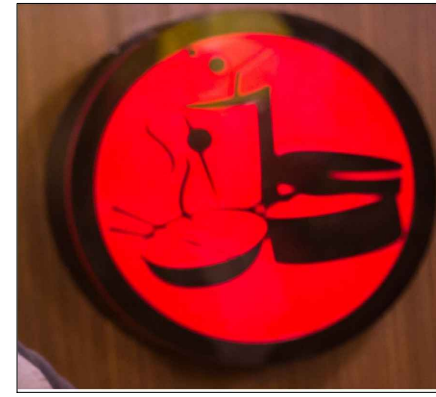

SUPER MEAL CIRCLE  
CODE-C(14"X14")



CHOPSTIK SMALL  
CIRCLE  
CODE- D(7"X7")



CHOPSTIK LARGE  
CIRCLE  
CODE- E(12"X12")



PAN FRIED CIRCLE  
CODE- F(13"X13")



KADHAI CIRCLE  
CODE- G(12"X12")



THUKPA CIRCLE  
CODE-H(8"X8")



STEAM CIRCLE  
SMALL  
CODE -I(9"X9")



STEAM CIRCLE  
LARGE  
CODE -J(12"X12")



(12"X12", 12"X24"&24"X12")  
VEG RICE IN BEIJING SAUCE



(12"X12"&24"X12")  
VEGGIE FRIED RICE



(12"X24")  
MOMO REVOLUTION

**PROJECT**

WOW MOMO @ AHMEDABAD AIRPORT  
FOOD COURT, GUJARAT.

**CLIENT**

WOW MOMO

**NOTE:**

THIS DRAWING & DESIGN IS THE COPYRIGHT OF THE DESIGNER. NO PORTION MAY BE REPRODUCED WITHOUT THE WRITTEN PERMISSION OF THE DESIGNERS

1. ALL DIMENSIONS ARE INCLUDING FINISHES
2. DO NOT SCALE DRAWING. ONLY MENTIONED DIMENSIONS ARE TO BE CONSIDERED.
3. ALL DIMENSIONS MUST BE CHECKED BEFORE COMMENCING WORK ON SITE.
4. ANY DISCREPANCIES SHALL BE BROUGHT UNDER THE NOTICE OF ARCHITECTS PRIOR COMMENCEMENT OF WORK.

**REVISION**

S.NO.	REMARKS	DATE
1	REV 1	.....
2	REV 2	
3	REV 3	
4	REV 4	
5	REV 5	
6	REV 6	
7	REV 7	
8	REV 8	



**CONSULTANT**

**CONSULTANT**


**RELEASE FOR**

INFORMATION	TENDER	CONSTRUCTION	ASBUILT
-------------	--------	--------------	---------


**TITLE**

BRANDING CIRCLE ELEVATION'S


DATE	04-10-2023
SCALE	NTS
DRAWN BY	VEDPAL
CHECKED BY	RR.
PRINTED BY	---
DWG. NO.	IA-203B

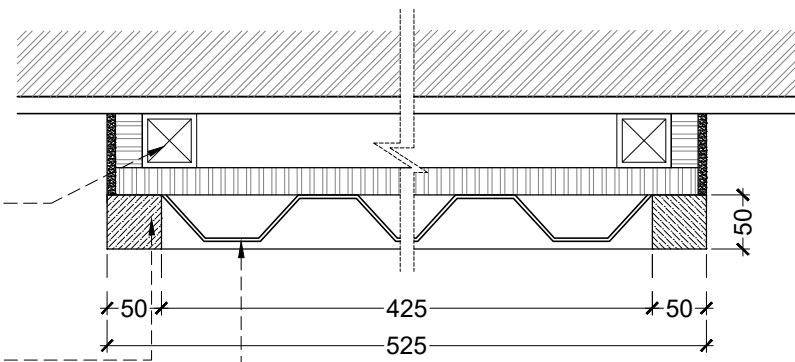


**DETAIL-Y2**  
TYPICAL BULKHEAD & CEILING  
CORRUGATED CLADDING DETAIL

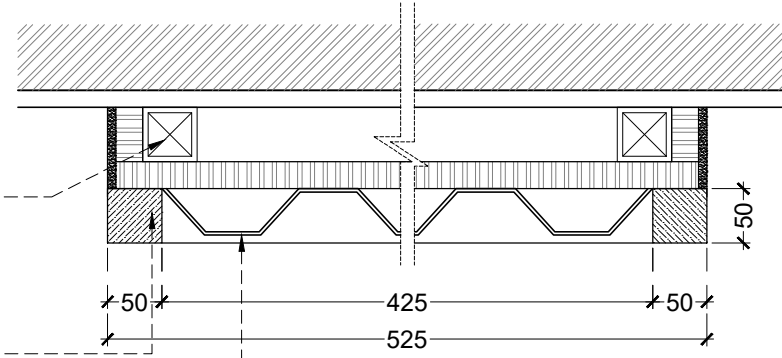


**DETAIL-Y3**  
TYPICAL BULKHEAD & CEILING  
CORRUGATED CLADDING DETAIL

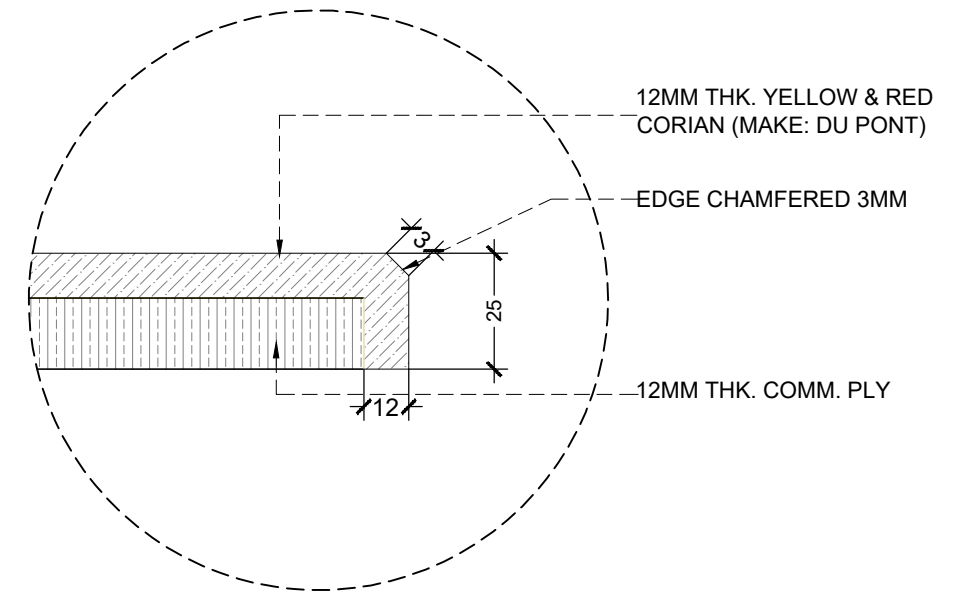

**DETAIL-X1**  
TYPICAL CORIAN EDGE DETAIL

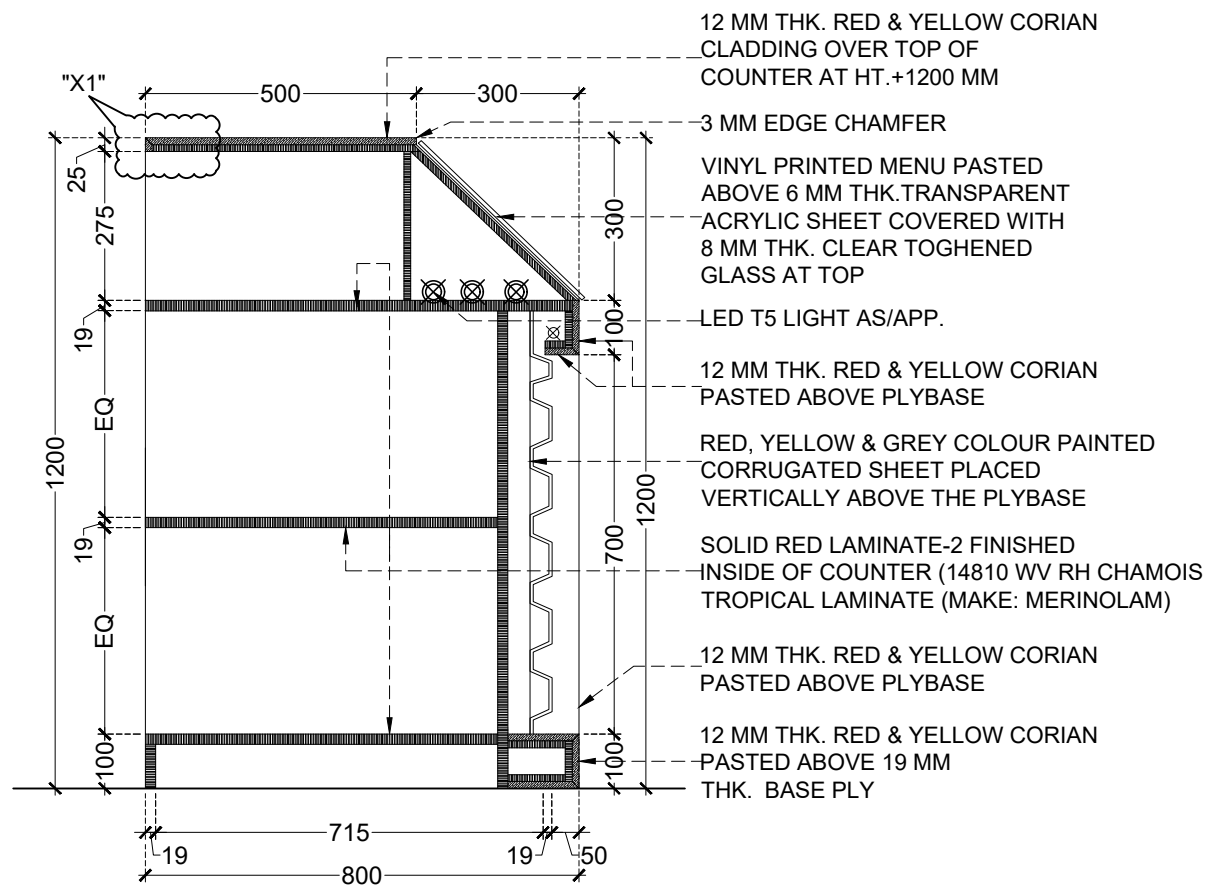

**TYPICAL COUNTER SECTION**

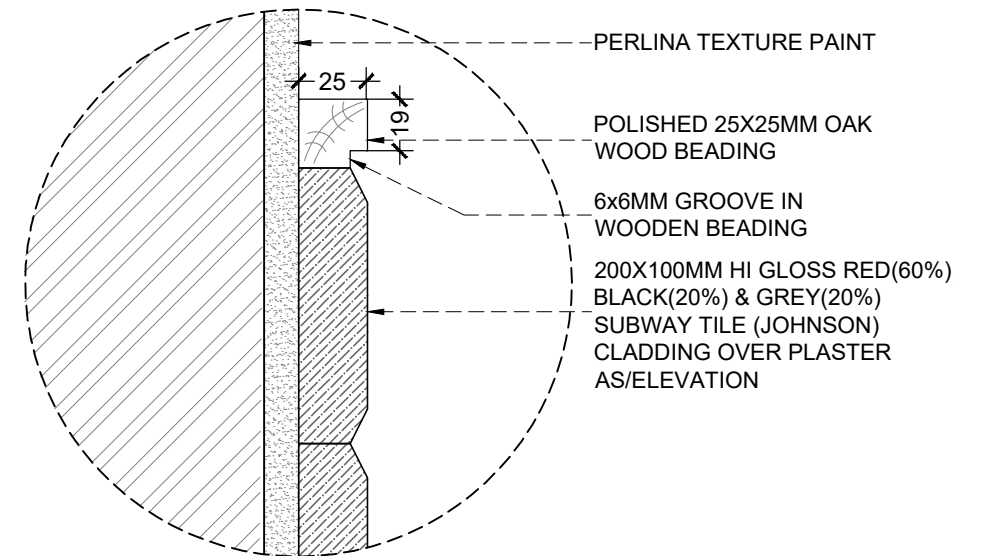

**DETAIL-Y1**  
TYPICAL SECTIONAL DETAIL FOR BEADING

**PROJECT**  
WOW MOMO & WOW CHINA  
@ AHMEDABAD AIRPORT  
FOOD COURT, GUJARAT.

**CLIENT**  
WOW MOMO & WOW CHINA

**NOTE:**

THIS DRAWING & DESIGN IS THE COPYRIGHT OF THE DESIGNER. NO PORTION MAY BE REPRODUCED WITHOUT THE WRITTEN PERMISSION OF THE DESIGNERS

1. ALL DIMENSIONS ARE INCLUDING FINISHES
2. DO NOT SCALE DRAWING. ONLY MENTIONED DIMENSIONS ARE TO BE CONSIDERED.
3. ALL DIMENSIONS MUST BE CHECKED BEFORE COMMENCING WORK ON SITE.
4. ANY DISCREPANCIES SHALL BE BROUGHT UNDER THE NOTICE OF ARCHITECTS PRIOR COMMENCEMENT OF WORK.

**REVISION**

S.NO.	REMARKS	DATE
1	REV 1	00/00/00
2	REV 2	00/00/00
3	REV 3	00/00/00
4	REV 4	00/00/00
5	REV 5	00/00/00
6	REV 6	00/00/00
7	REV 7	00/00/00
8	REV 8	00/00/00

**ARCHITECT / INTERIOR DESIGN**

**OS ARCHITECTURE PLANNING**  
STUDIO  
FLAT NO-13 DDA SFS  
FLAT POCKET -1 SEC-6 DWARKA,  
NEW DELHI-110075  
EMAIL:-infoatats@gmail.com  
OFF-011-40314174, MOB:9910315171

**CONSULTANT**

-----  
-----  
**CONSULTANT**  
-----  
-----

**RELEASE FOR**

INFORMATION	TENDER	CONSTRUCTION	AS BUILT

**TITLE**

TYPICAL DETAILS			
DATE	04/10/2023	CHECKED BY	RR
SCALE	N.T.S	PRINTED BY	-----
DWG. NO.	IA-300	DRAWN BY	VEDPAL





# ARCH THINK STUDIO

ARCHITECTURE : PLANNING : INTERIOR : FURNITURE

**Do you have any questions?**

**Contact Us :**

Flat no. 13, DDA SFS FLAT Pocket -1  
Sec.-6, Dwarka, New Delhi -110075.

Email: [infoatats@gmail.com](mailto:infoatats@gmail.com)

Office: 011-35559249,

Mobile:+91- 9910315171

+91-9711400028

Follow us :

