


SR.	SYMBOL	DESCRIPTION	QUANTITY	BOTTOM HT.
1		100MM DIA X 5W. CONCEALED NONDIMMABLE SPOT LIGHT.	40 NOS	
2		RANDOM SIZE 4W. NON DIMMABLE LED BULB.	84 NOS	
3		80MM DIA X 4W. NON DIMMABLE LED BULB.	38 NOS	
4		4850MM DIA CHANDELIER HANGING LIGHT WITH 34MM DIA X 4W. NON DIMMABLE LED BULB.	38 NOS	2531MM
5		75MM DIA X 9W. CEILING SURFACE MOUNTED NON DIMMABLE CYLINDRICAL LIGHT	12 NOS	
6		CEILING SURFACE MOUNTED 5W NON DIMMABLE LIGHT	5 NOS	
7		450MM DIA X 6W. SUSPENDED NON DIMMABLE DECORATIVE LIGHT	4 NOS	1750MM
8		450MM DIA X 6W. SUSPENDED NON DIMMABLE DECORATIVE LIGHT	3 NOS	1700MM
9		450MM DIA X 6W. SUSPENDED NON DIMMABLE DECORATIVE LIGHT	2 NOS	1750MM
10		450MM DIA X 6W. SUSPENDED NON DIMMABLE DECORATIVE LIGHT	6 NOS	2100MM
11		450MM DIA X 6W. SUSPENDED NON DIMMABLE DECORATIVE LIGHT	1 NO	1975MM
12		30MM DIA X 600MM HT. X 5W. SUSPENDED DECORATIVE LIGHT	6 NOS	1975MM
13		100MM DIA X 4W. NON DIMMABLE WALL LIGHT WITH BRACKET.	9 NOS	1950MM
14		4 W. LED STRIP LIGHT	887 RFT	887 RFT
15		36W LED PANEL 600*600 ARE REMARKABLY SLIM AT 12.5MM, IN NATURAL WHITE(4000K) COMPLETE WITH LED DRIVER. ALL HAVE A WHITE TRIM 595MM X 595MM (STANDARD CEILING SIZE). FOR DISH WASH AREA.	10 NOS	
16		U V Double Skin SS Exhaust Hoods.	7 NOS	
17		36W LED LIGHT (2 X 18), MAKE:- PHILIPS. 16W LED LIGHT (2 X 8), MAKE:- PHILIPS. 16W LED LIGHT (1 X 8), MAKE:- PHILIPS.	6 NOS 1 NO 1 NO	

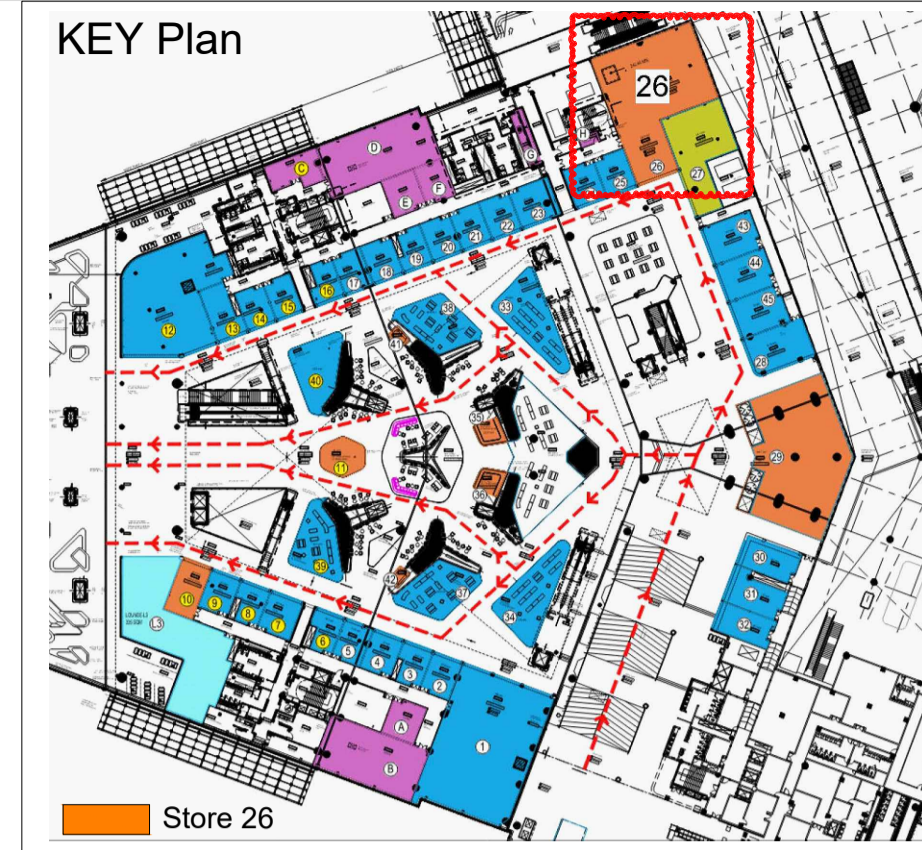

Node L4 Departure Level

PROJECT:
DIAL PHASE 3A EXPANTION

DEVELOPER:
GAR
Creating tomorrow today
Delhi International Airport Limited

CLIENT:
tfs
Travel Food Services
Travel Food Services Pvt Ltd
Shiv Sagar Estate, A-Block, 1st floor A.B.
Road Worli, Mumbai - 400 018
INDIA.
www.travelfoodservices.com

CONCEPT & INTERIOR DESIGNER:
AURA DEZYNE
C-45, North Bombay C.H.S.,
Juhu, Mumbai - 400049.
Tel:- +91 22 26127475

MEP CONSULTANT:
MEPTEK CONSULTANTS
209, Sumer Kendra, Behind Mahindra Towers,
Pandurang Budhkar Marg, Worli,
Mumbai - 400018

GENERAL NOTES:
1. THIS DRAWING CAN BE SCALED AS PER THE PAPER SIZE
2. ALL DIMENSIONS ARE IN MM UNLESS SPECIFIED
3. REFER TO BOQ FOR DETAILED SPECIFICATIONS
4. IN CASE OF ANY DISCREPANCY IN THE DRAWING, PLEASE INFORM THE AURA DEZYNE TEAM PRIOR TO EXECUTION.

TFS / DIAL DESIGN:
CHECKED BY: _____ APPROVED BY: _____

ALL DIMENSIONS ARE IN MM, UNLESS OTHERWISE SPECIFIED. REVISION NO
00

REV. NO.	DESCRIPTION	DATE

PROJECT NO.: FH-D-109/24-25
DWG NO.: DIAL-T1-TFS-ID_PL-L4-DWG-011
PROJECT: FOOD HALL OF STORE 26 AT L4 LEVEL
SCALE: 1:45
SHEET SIZE: A1
SHEET NO: 11
DWG TITLE: PROPOSED LIGHTING LAYOUT

RELEASED FOR: INFORMATION REVIEW CONSTRUCTION AS-BUILT