


GARBAGE SEGREGATION

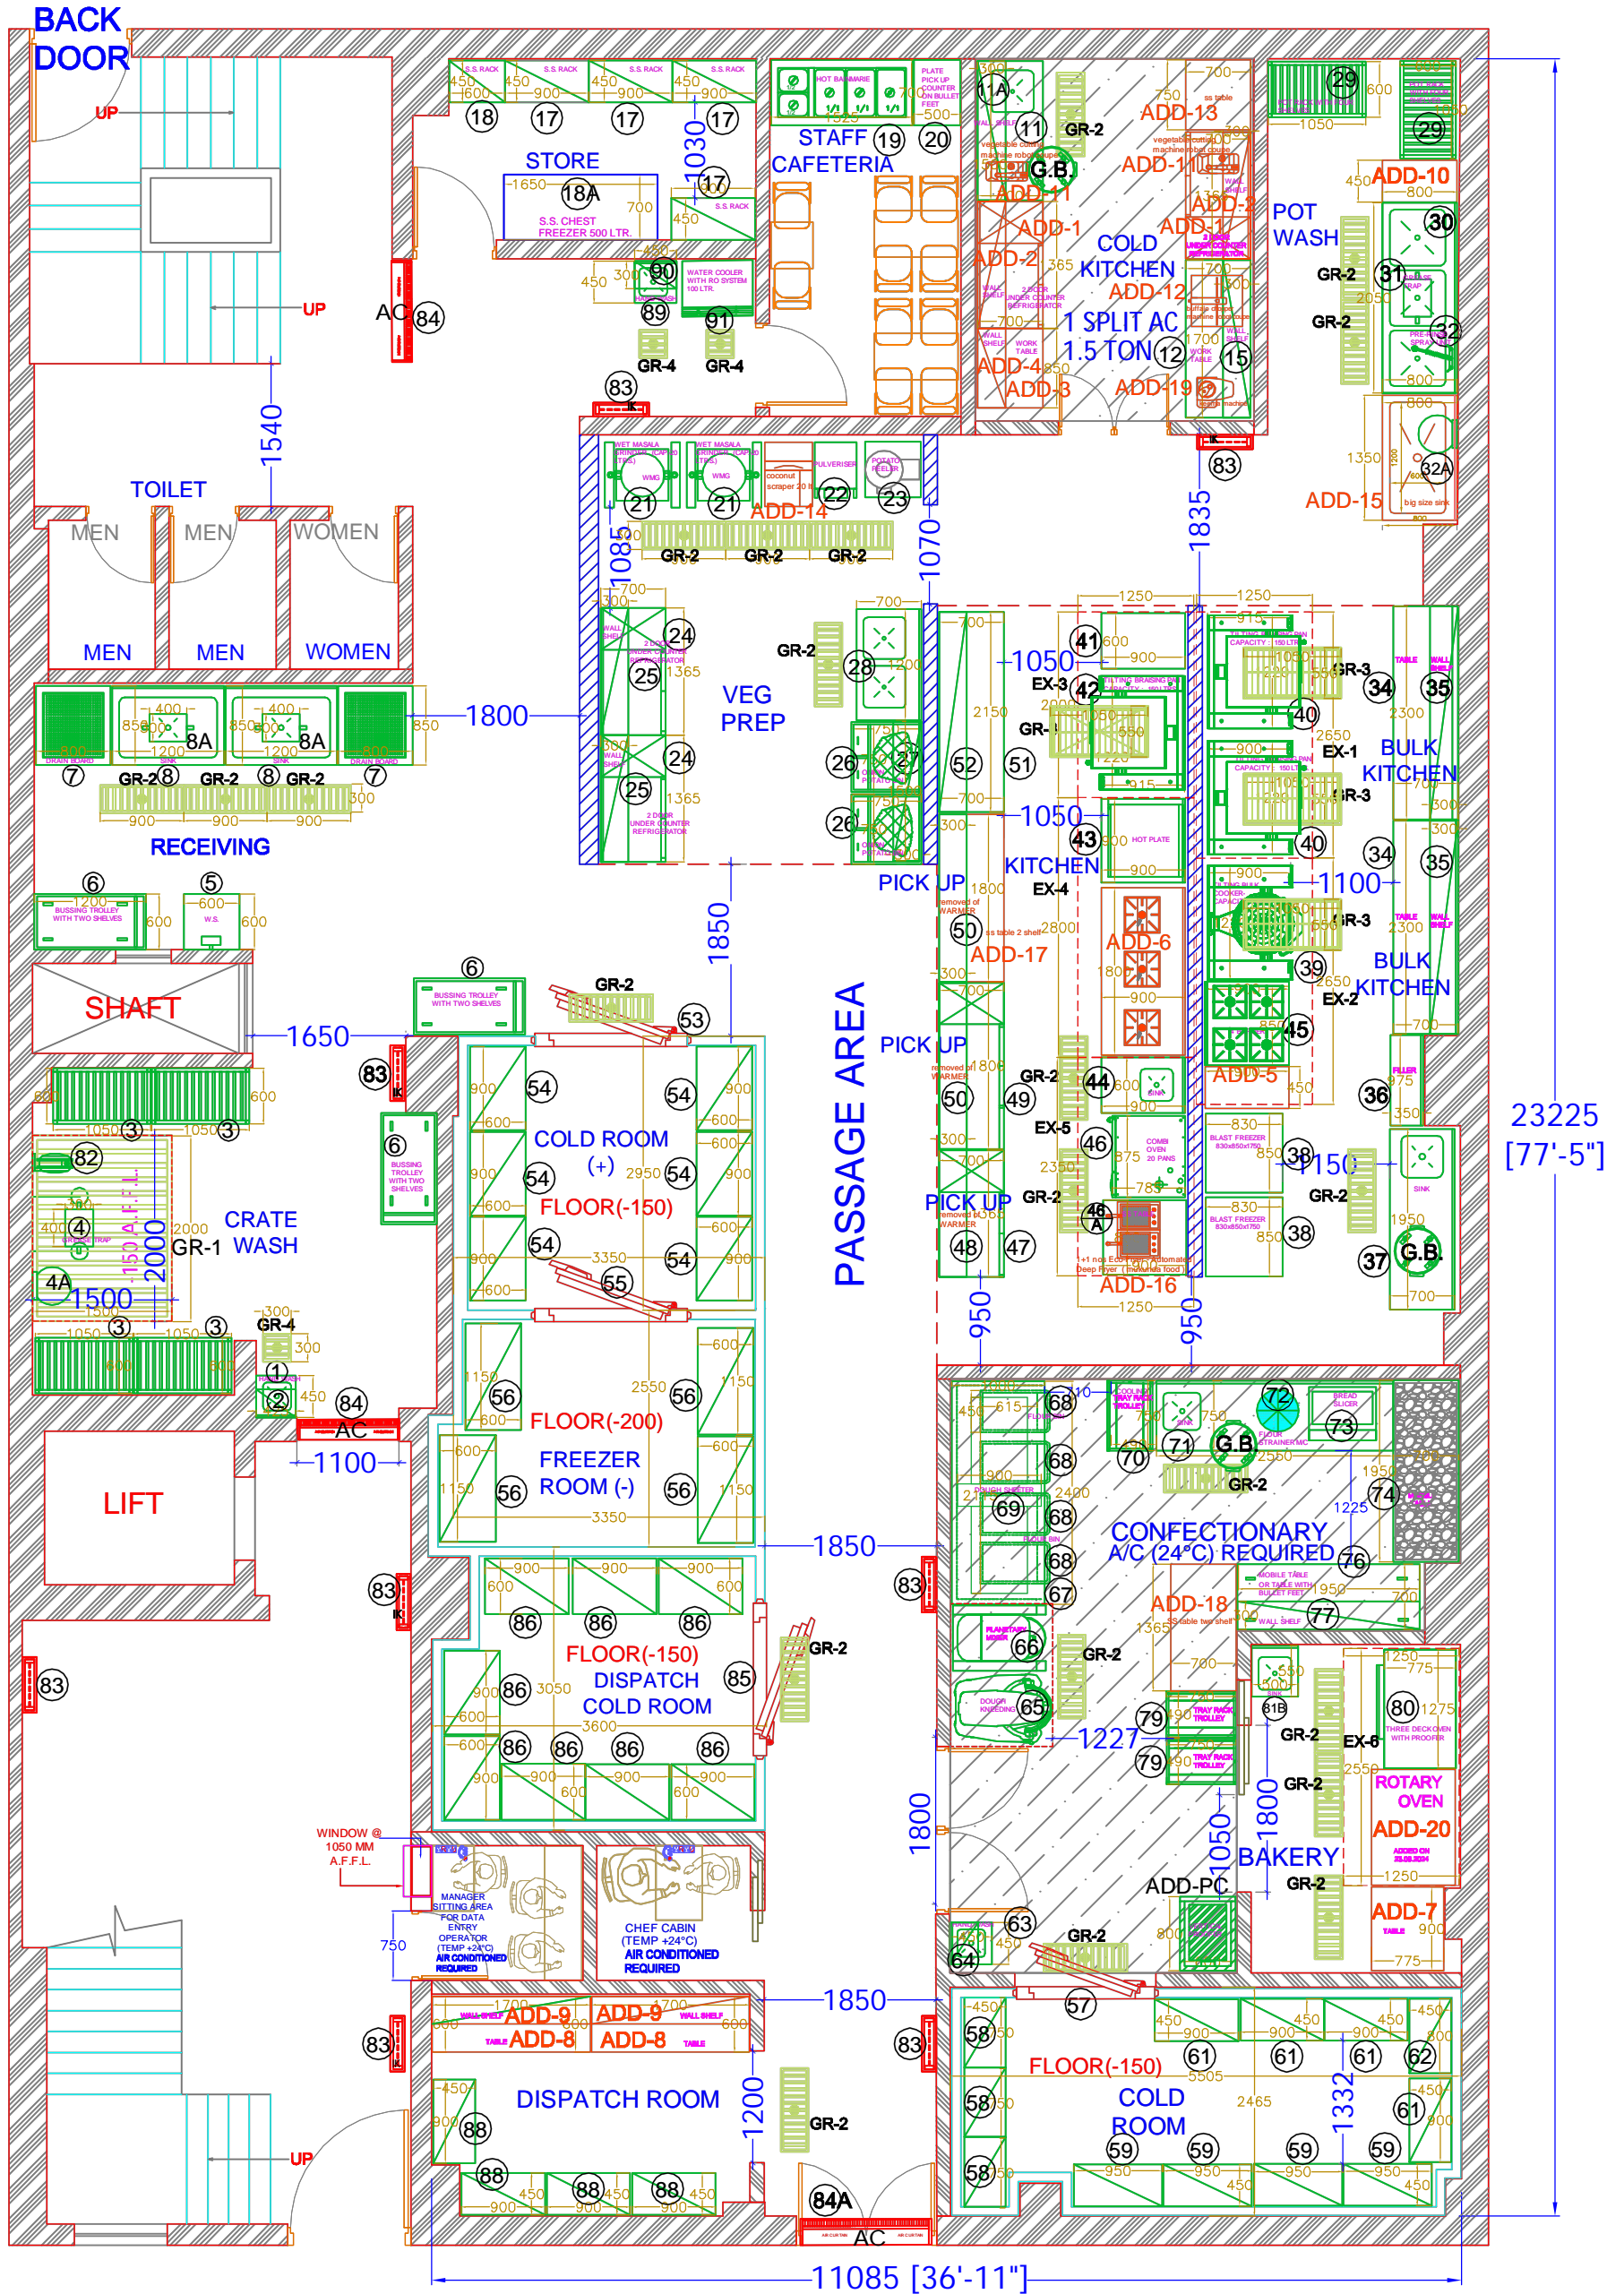

R.OFFICE: 186, BLOCK C-2C, POCKET 12, JANAK PURI, NEW DELHI, 110058
e mail: design@classconsultants.in Office: +919212501725

THESE DRAWING AND SPECIFICATIONS ARE THE PROPERTY OF CLASS HOSPITALITY CONSULTANTS AND SHALL NOT BE COPIED OR REPRODUCED WITHOUT THEIR WRITTEN PERMISSION.

PROJECT TITLE
TFS BASE KITCHEN
MATIYALA DWARKA

DRAWING TITLE:
EQUIPMENT LAYOUT PLAN

20/07/2024/LAYOUT/REV000

DESIGN:

PREPARED BY:

VIBHA

SCALE: NTS

CAD FILE:F:/PROJECT

REV NO.

001

002

003

004

REVISION DATE


12/08/2024

26/08/2024

05/09/2024

18/09/2024

PROJECT DATE: 19/07/2024

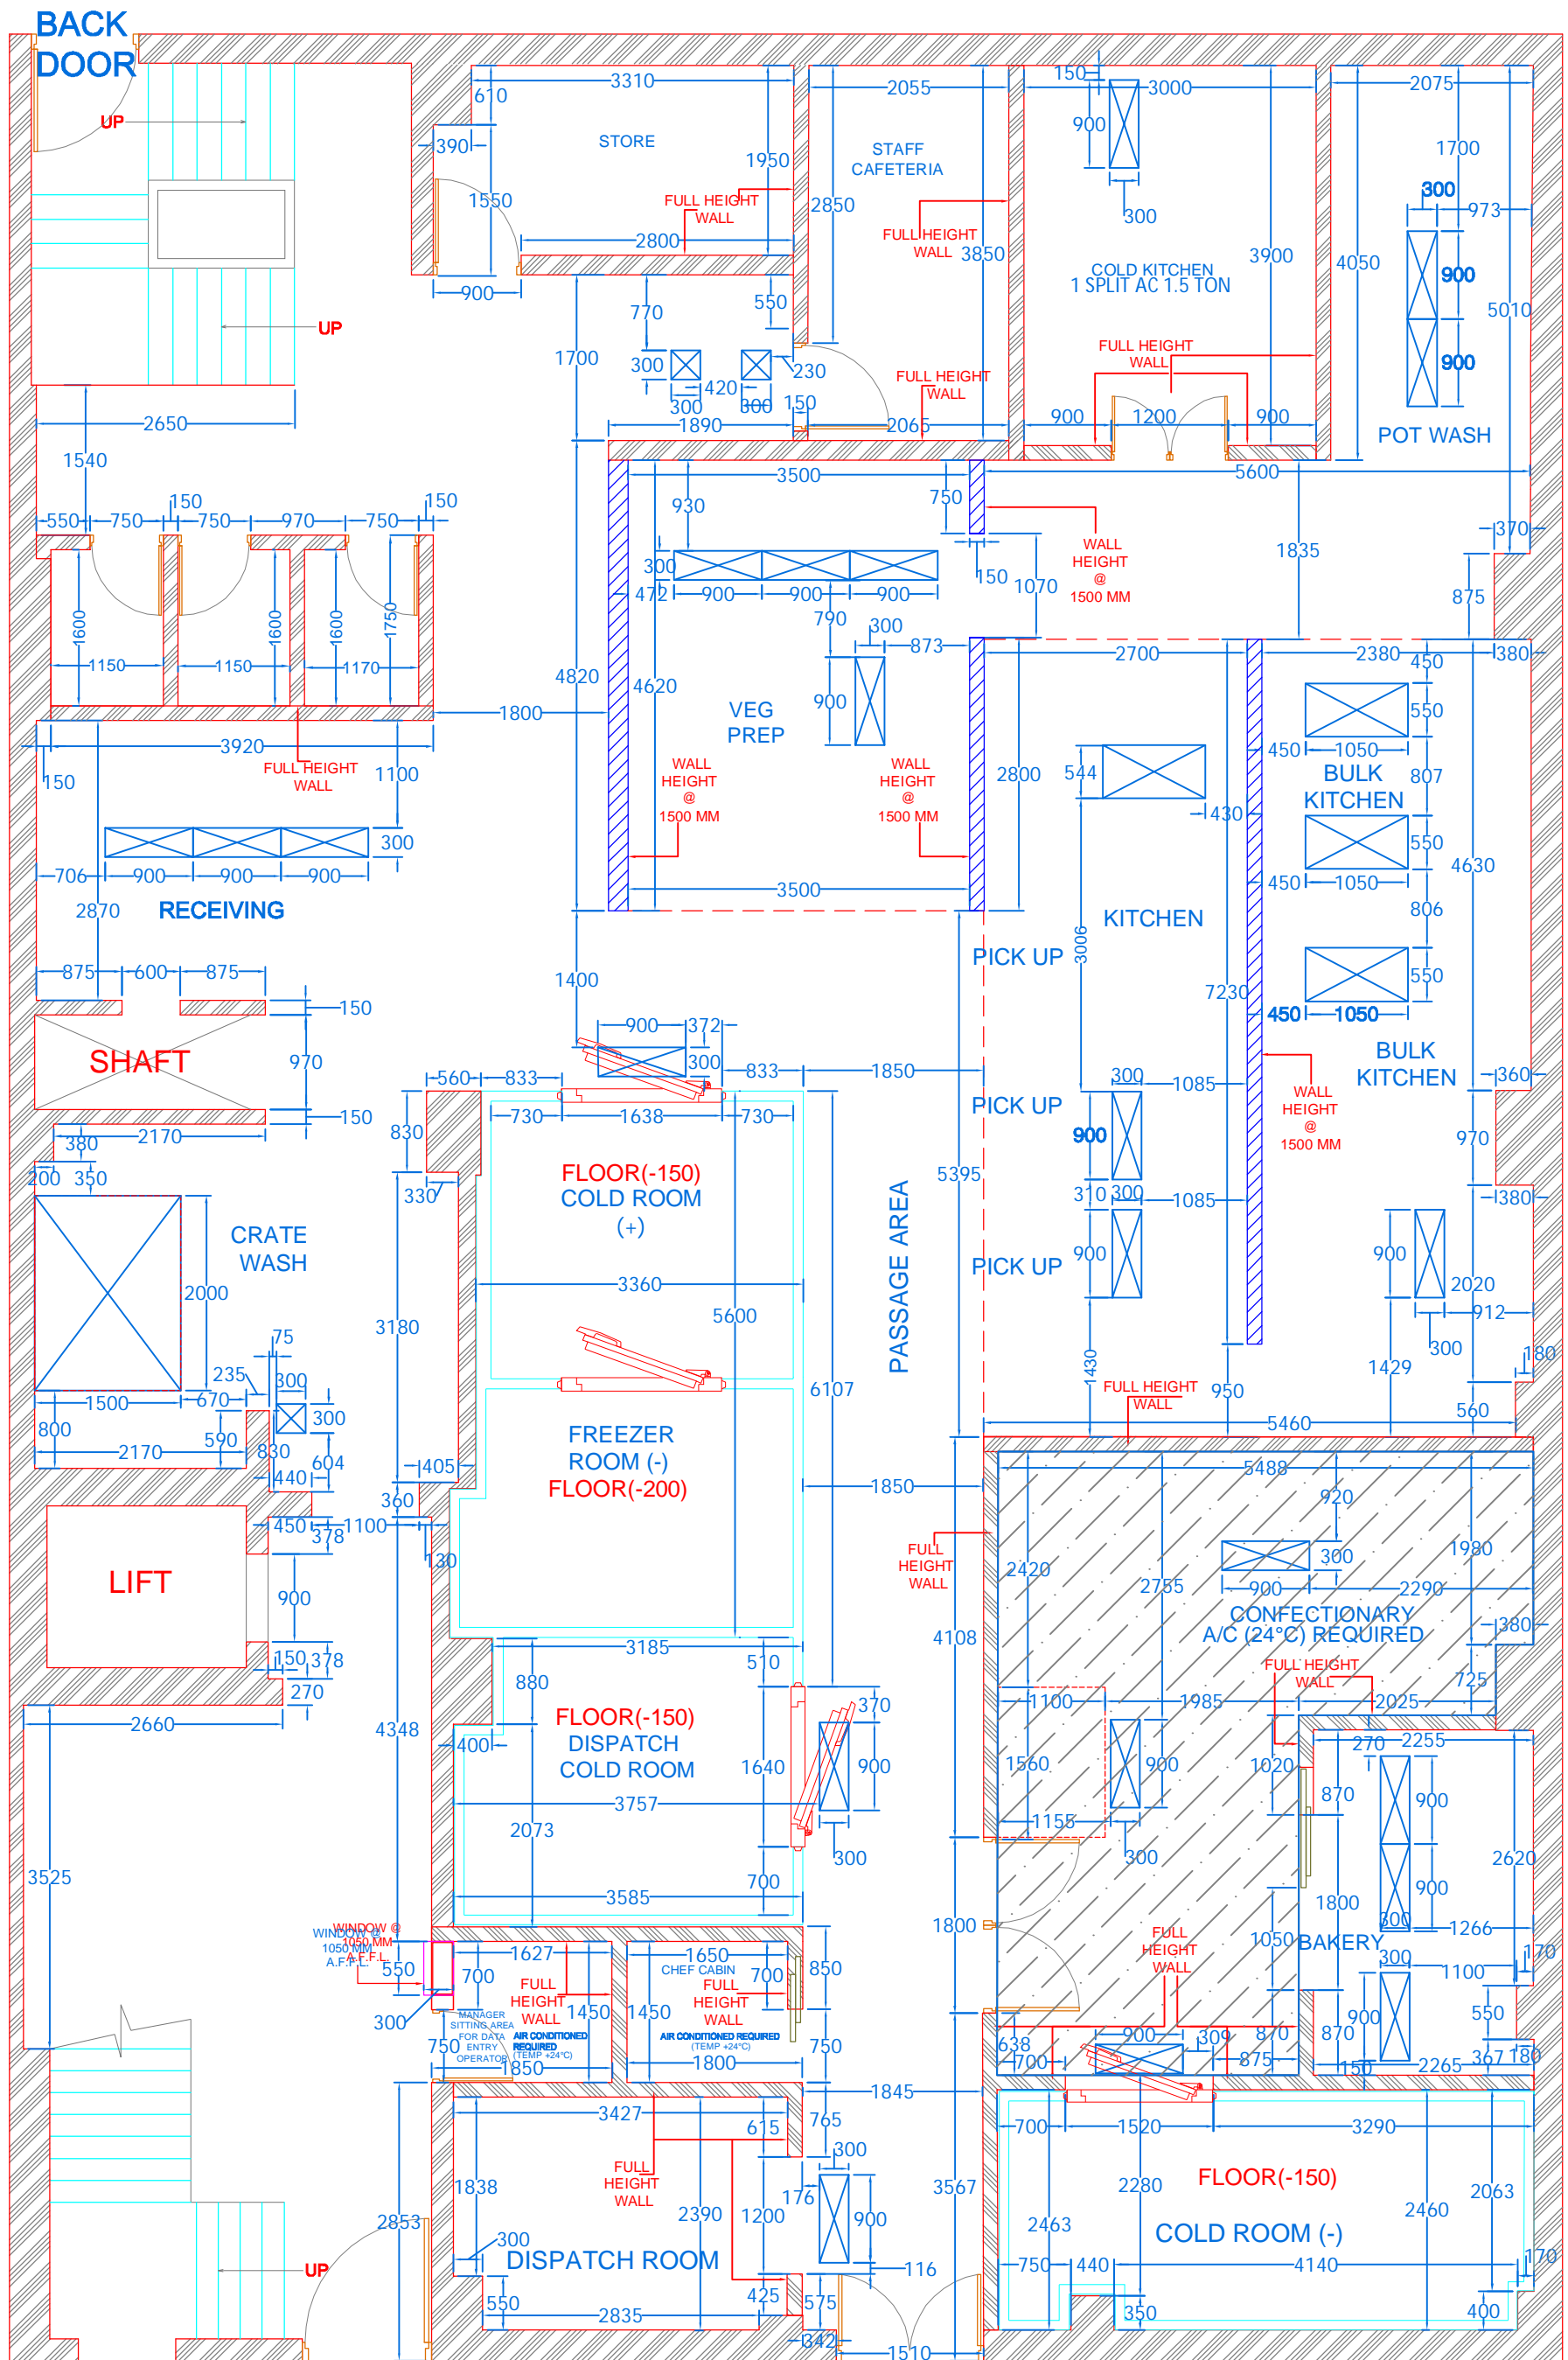

R.OFFICE: 186, BLOCK C-2C, POCKET 12, JANAK PURI, NEW DELHI, 110058
 e mail: design@classconsultants.in Office:+919212501725

THESE DRAWING AND SPECIFICATIONS ARE THE PROPERTY OF CLASS HOSPITALITY CONSULTANTS AND SHALL NOT BE COPIED OR REPRODUCED WITHOUT THEIR WRITTEN PERMISSION.

PROJECT TITLE
TFS BASE KITCHEN
MATIYALA DWARKA

DRAWING TITLE:
CIVIL LAYOUT PLAN

DESIGN:

PREPARED BY:
VIBHA

SCALE: NTS

REV NO.

000

000

000

000

REVISION DATE

00/00/2024

00/00/2024


00/00/2024

00/00/2024

20/07/2024/LAYOUT/REV000

CAD FILE:F:/PROJECT

PROJECT DATE: 19/07/2024

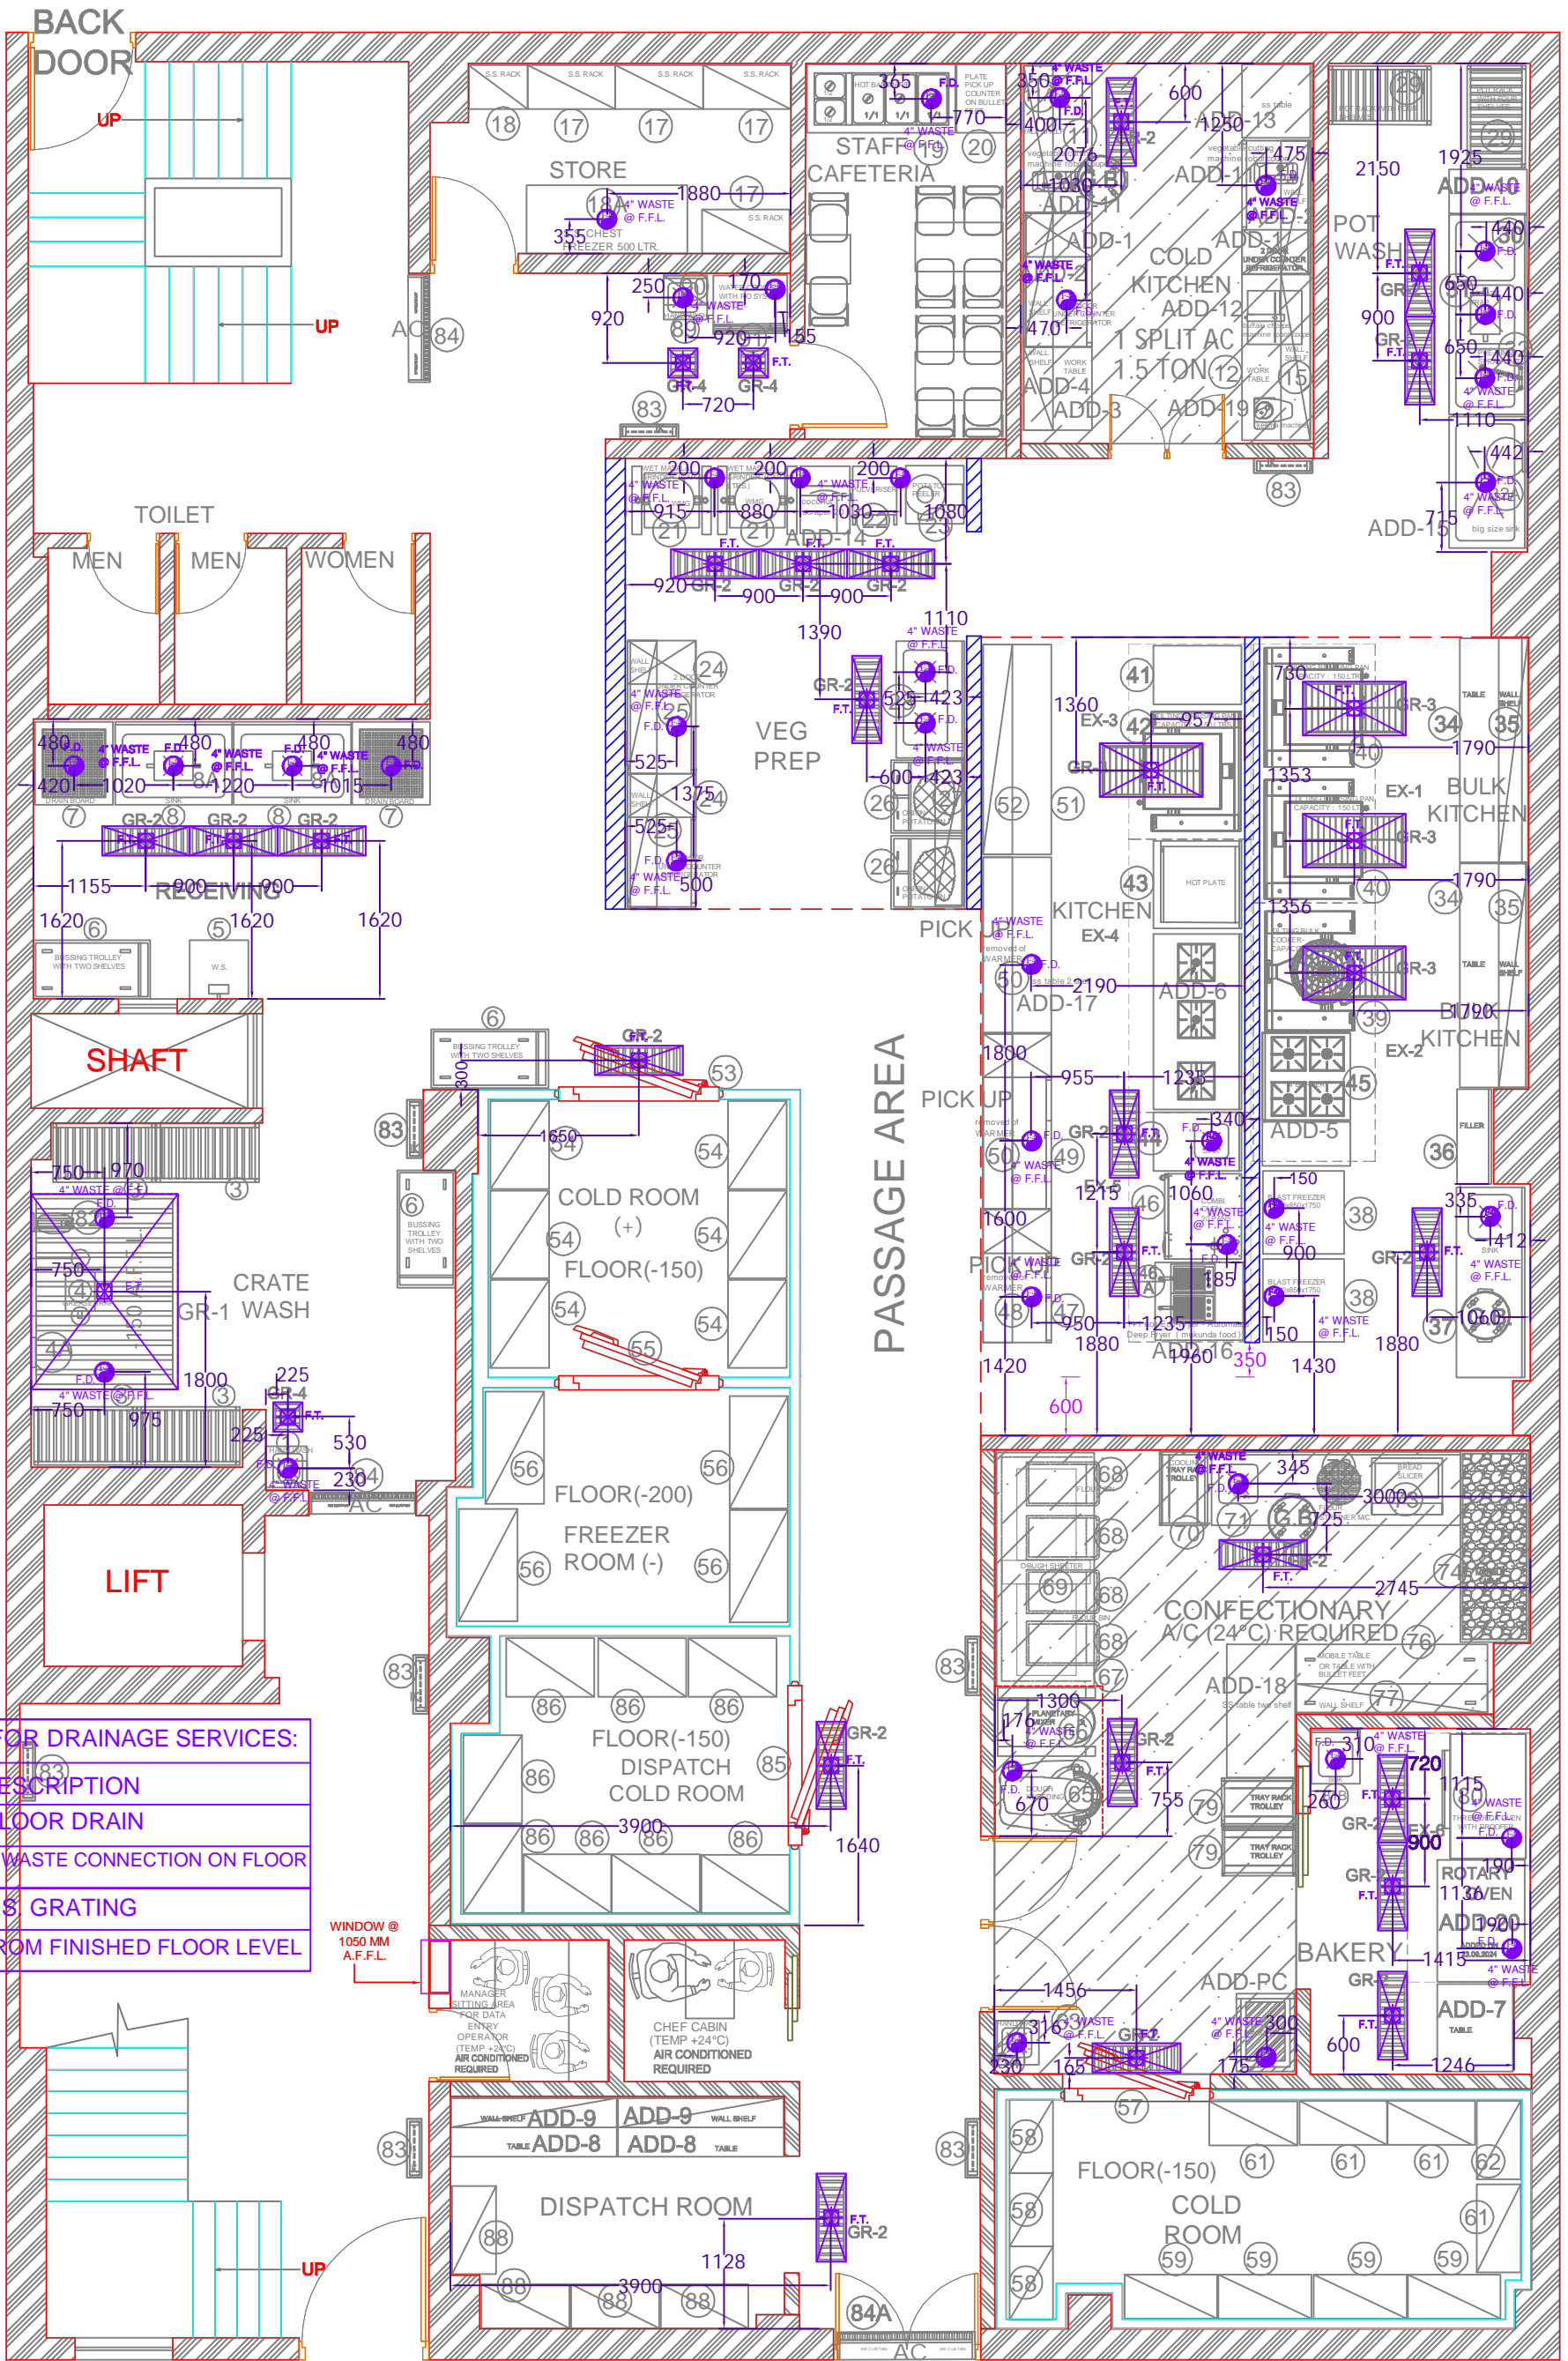

LEGENDS FOR DRAINAGE SERVICES:

SYMBOL	DESCRIPTION
	FLOOR DRAIN
	4" WASTE CONNECTION ON FLOOR
	S.S. GRATING
	FROM FINISHED FLOOR LEVEL

WINDOW @ 1050 MM A.F.F.L.



R.OFFICE: 186, BLOCK C-2C, POCKET 12, JANAK PURI, NEW DELHI, 110058
e mail: design@classconsultants.in Office:-919212501725

THESE DRAWING AND SPECIFICATIONS ARE THE PROPERTY OF CLASS HOSPITALITY CONSULTANTS AND SHALL NOT BE COPIED OR REPRODUCED WITHOUT THEIR WRITTEN PERMISSION.

PROJECT TITLE
TFS BASE KITCHEN
MATIYALA DWARKA

DRAWING TITLE:
DRAINAGE LAYOUT PLAN


20/07/2024/LAYOUT/REV000

DESIGN:
PREPARED BY:
VIBHA
SCALE: NTS

CAD FILE:F:/PROJECT


REV NO.	REVISION DATE
000	00/00/2024
000	00/00/2024
000	00/00/2024
000	00/00/2024

PROJECT DATE: 19/07/2024

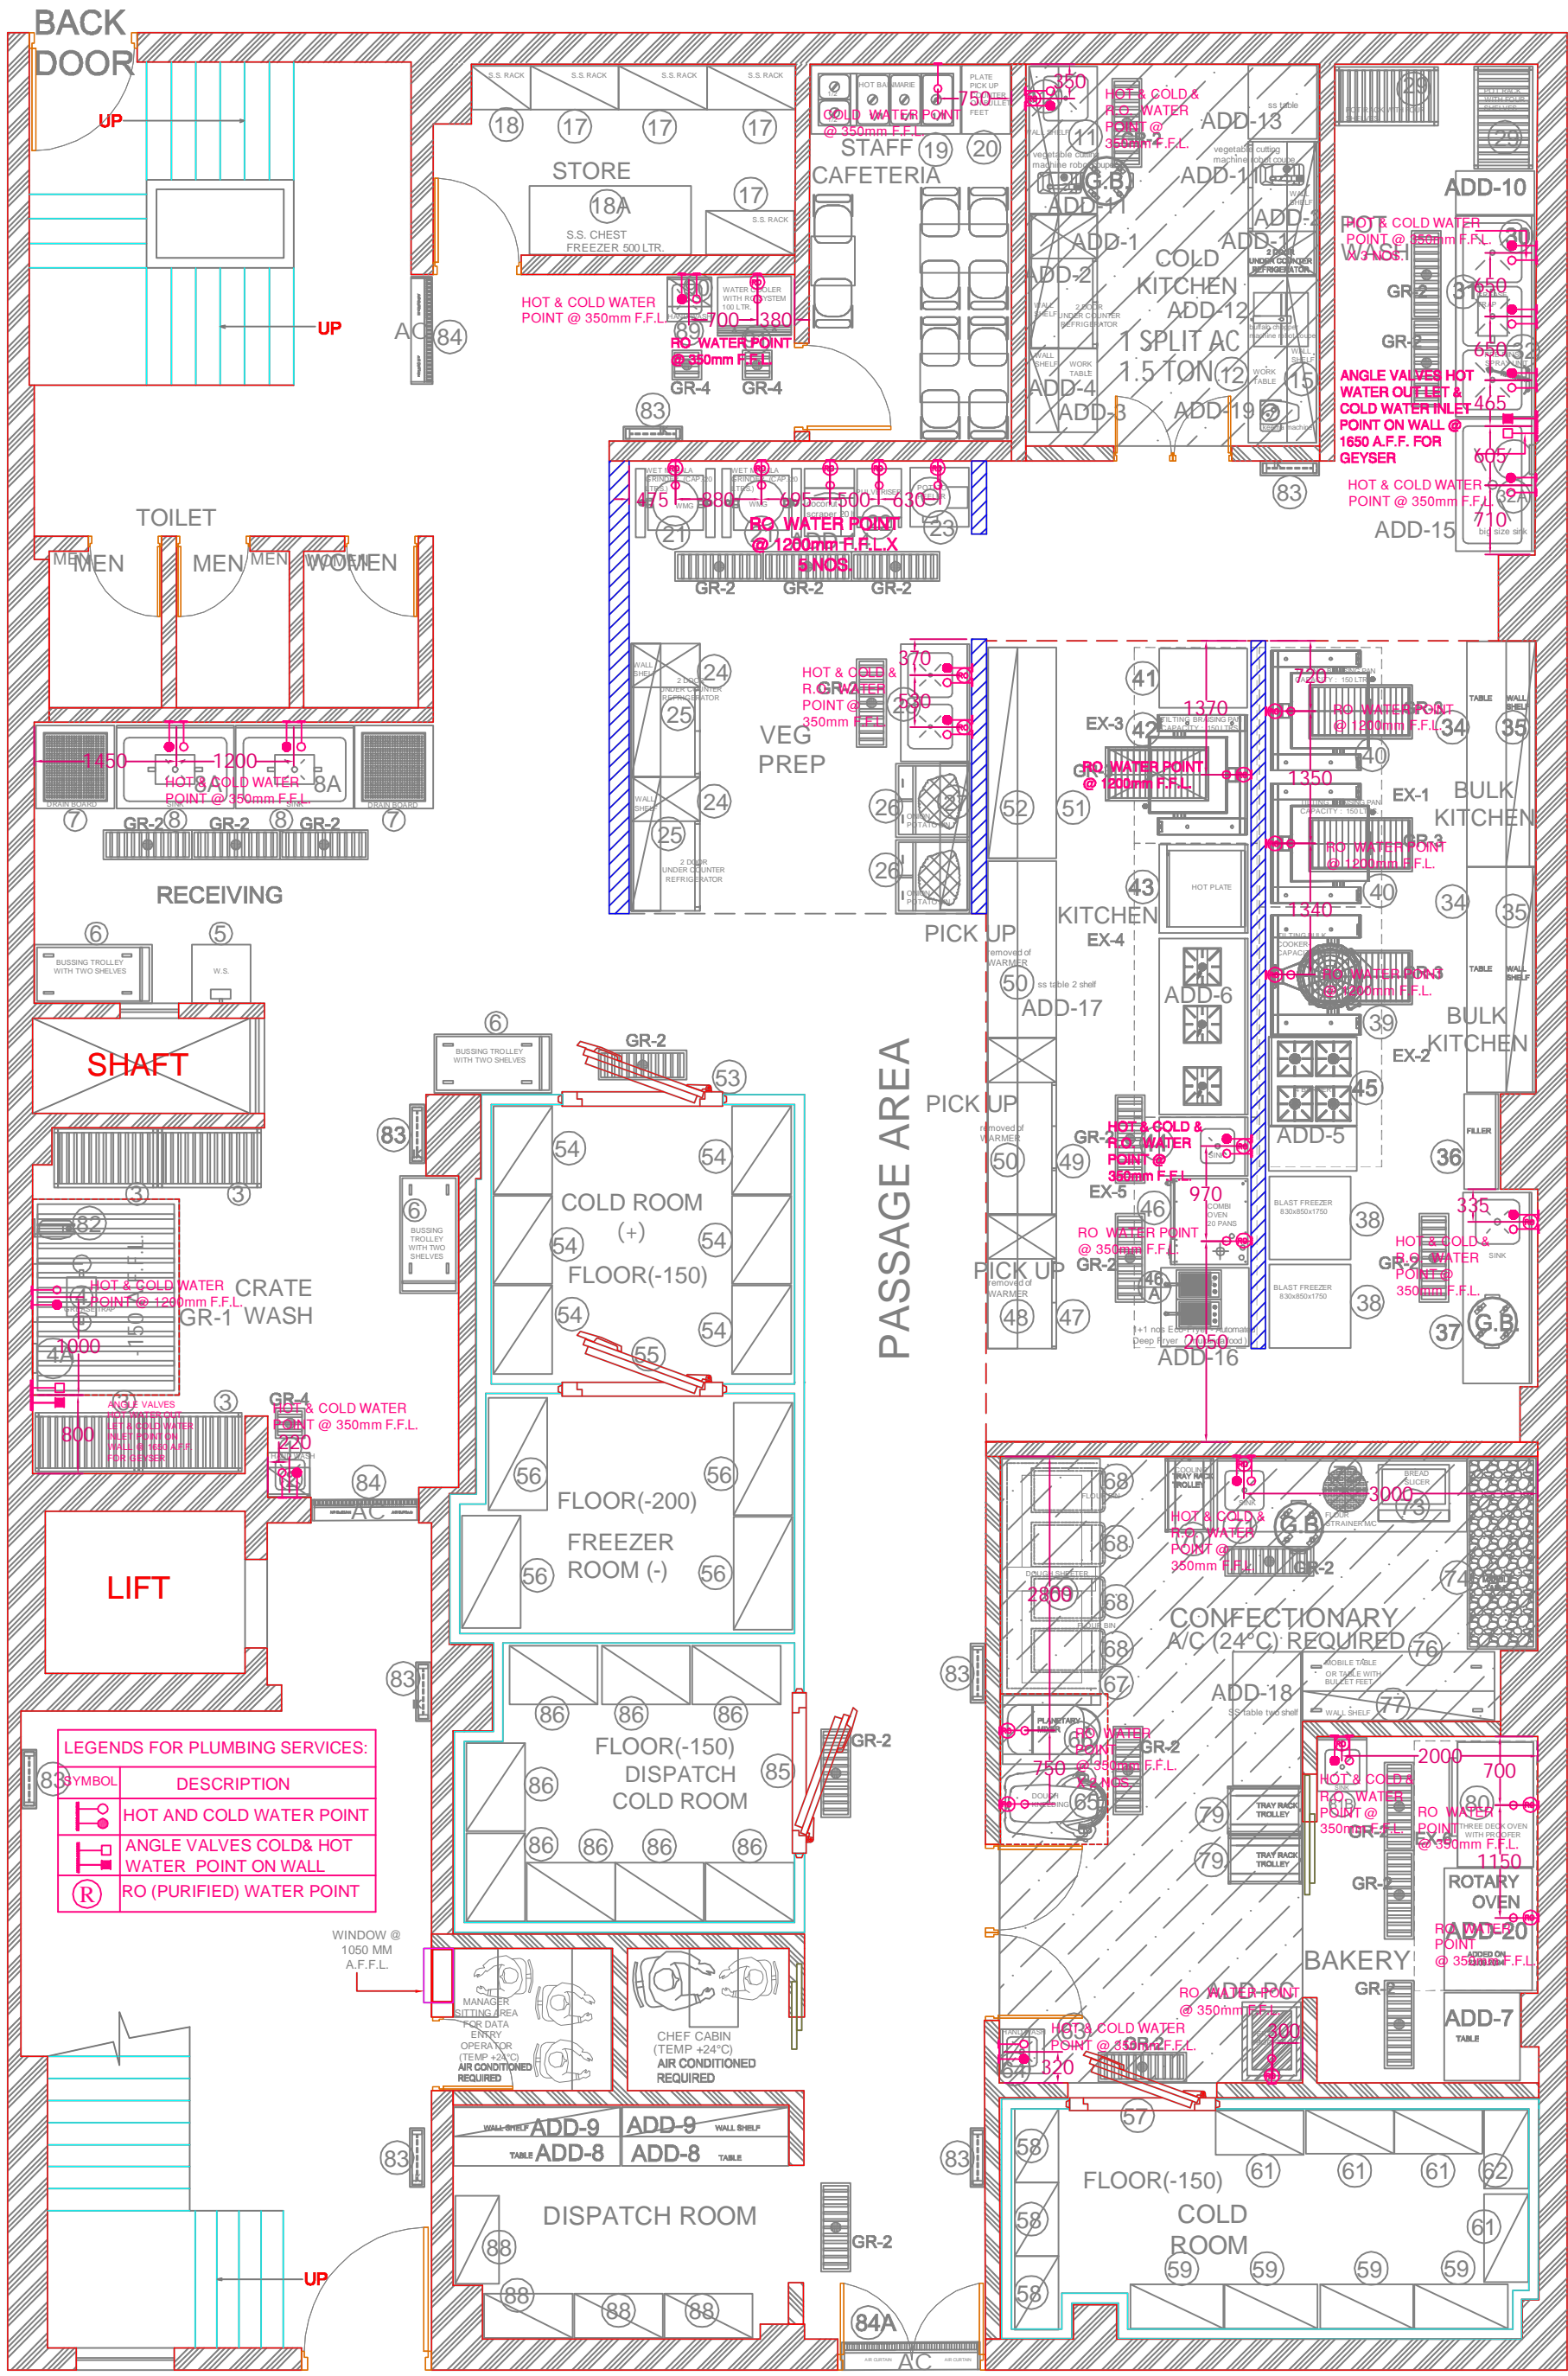

LEGENDS FOR PLUMBING SERVICES:

SYMBOL	DESCRIPTION
	HOT AND COLD WATER POINT
	ANGLE VALVES COLD & HOT WATER POINT ON WALL
	RO (PURIFIED) WATER POINT

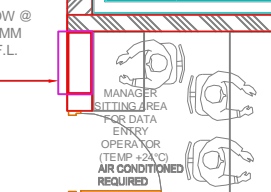

R.OFFICE: 186, BLOCK C-2C, POCKET 12, JANAK PURI, NEW DELHI, 110058
 e mail: design@classconsultants.in Office:-919212501725

THESE DRAWING AND SPECIFICATIONS ARE THE PROPERTY OF CLASS HOSPITALITY CONSULTANTS AND SHALL NOT BE COPIED OR REPRODUCED WITHOUT THEIR WRITTEN PERMISSION.

PROJECT TITLE
TFS BASE KITCHEN
MATIYALA DWARKA


DRAWING TITLE:
PLUMBING LAYOUT PLAN

20/07/2024/LAYOUT/REV000

DESIGN:
PREPARED BY:
SCALE: NTS
CAD FILE: F:/PROJECT

REV NO.	REVISION DATE
000	00/00/2024
000	00/00/2024
000	00/00/2024
000	00/00/2024

PROJECT DATE: 19/07/2024

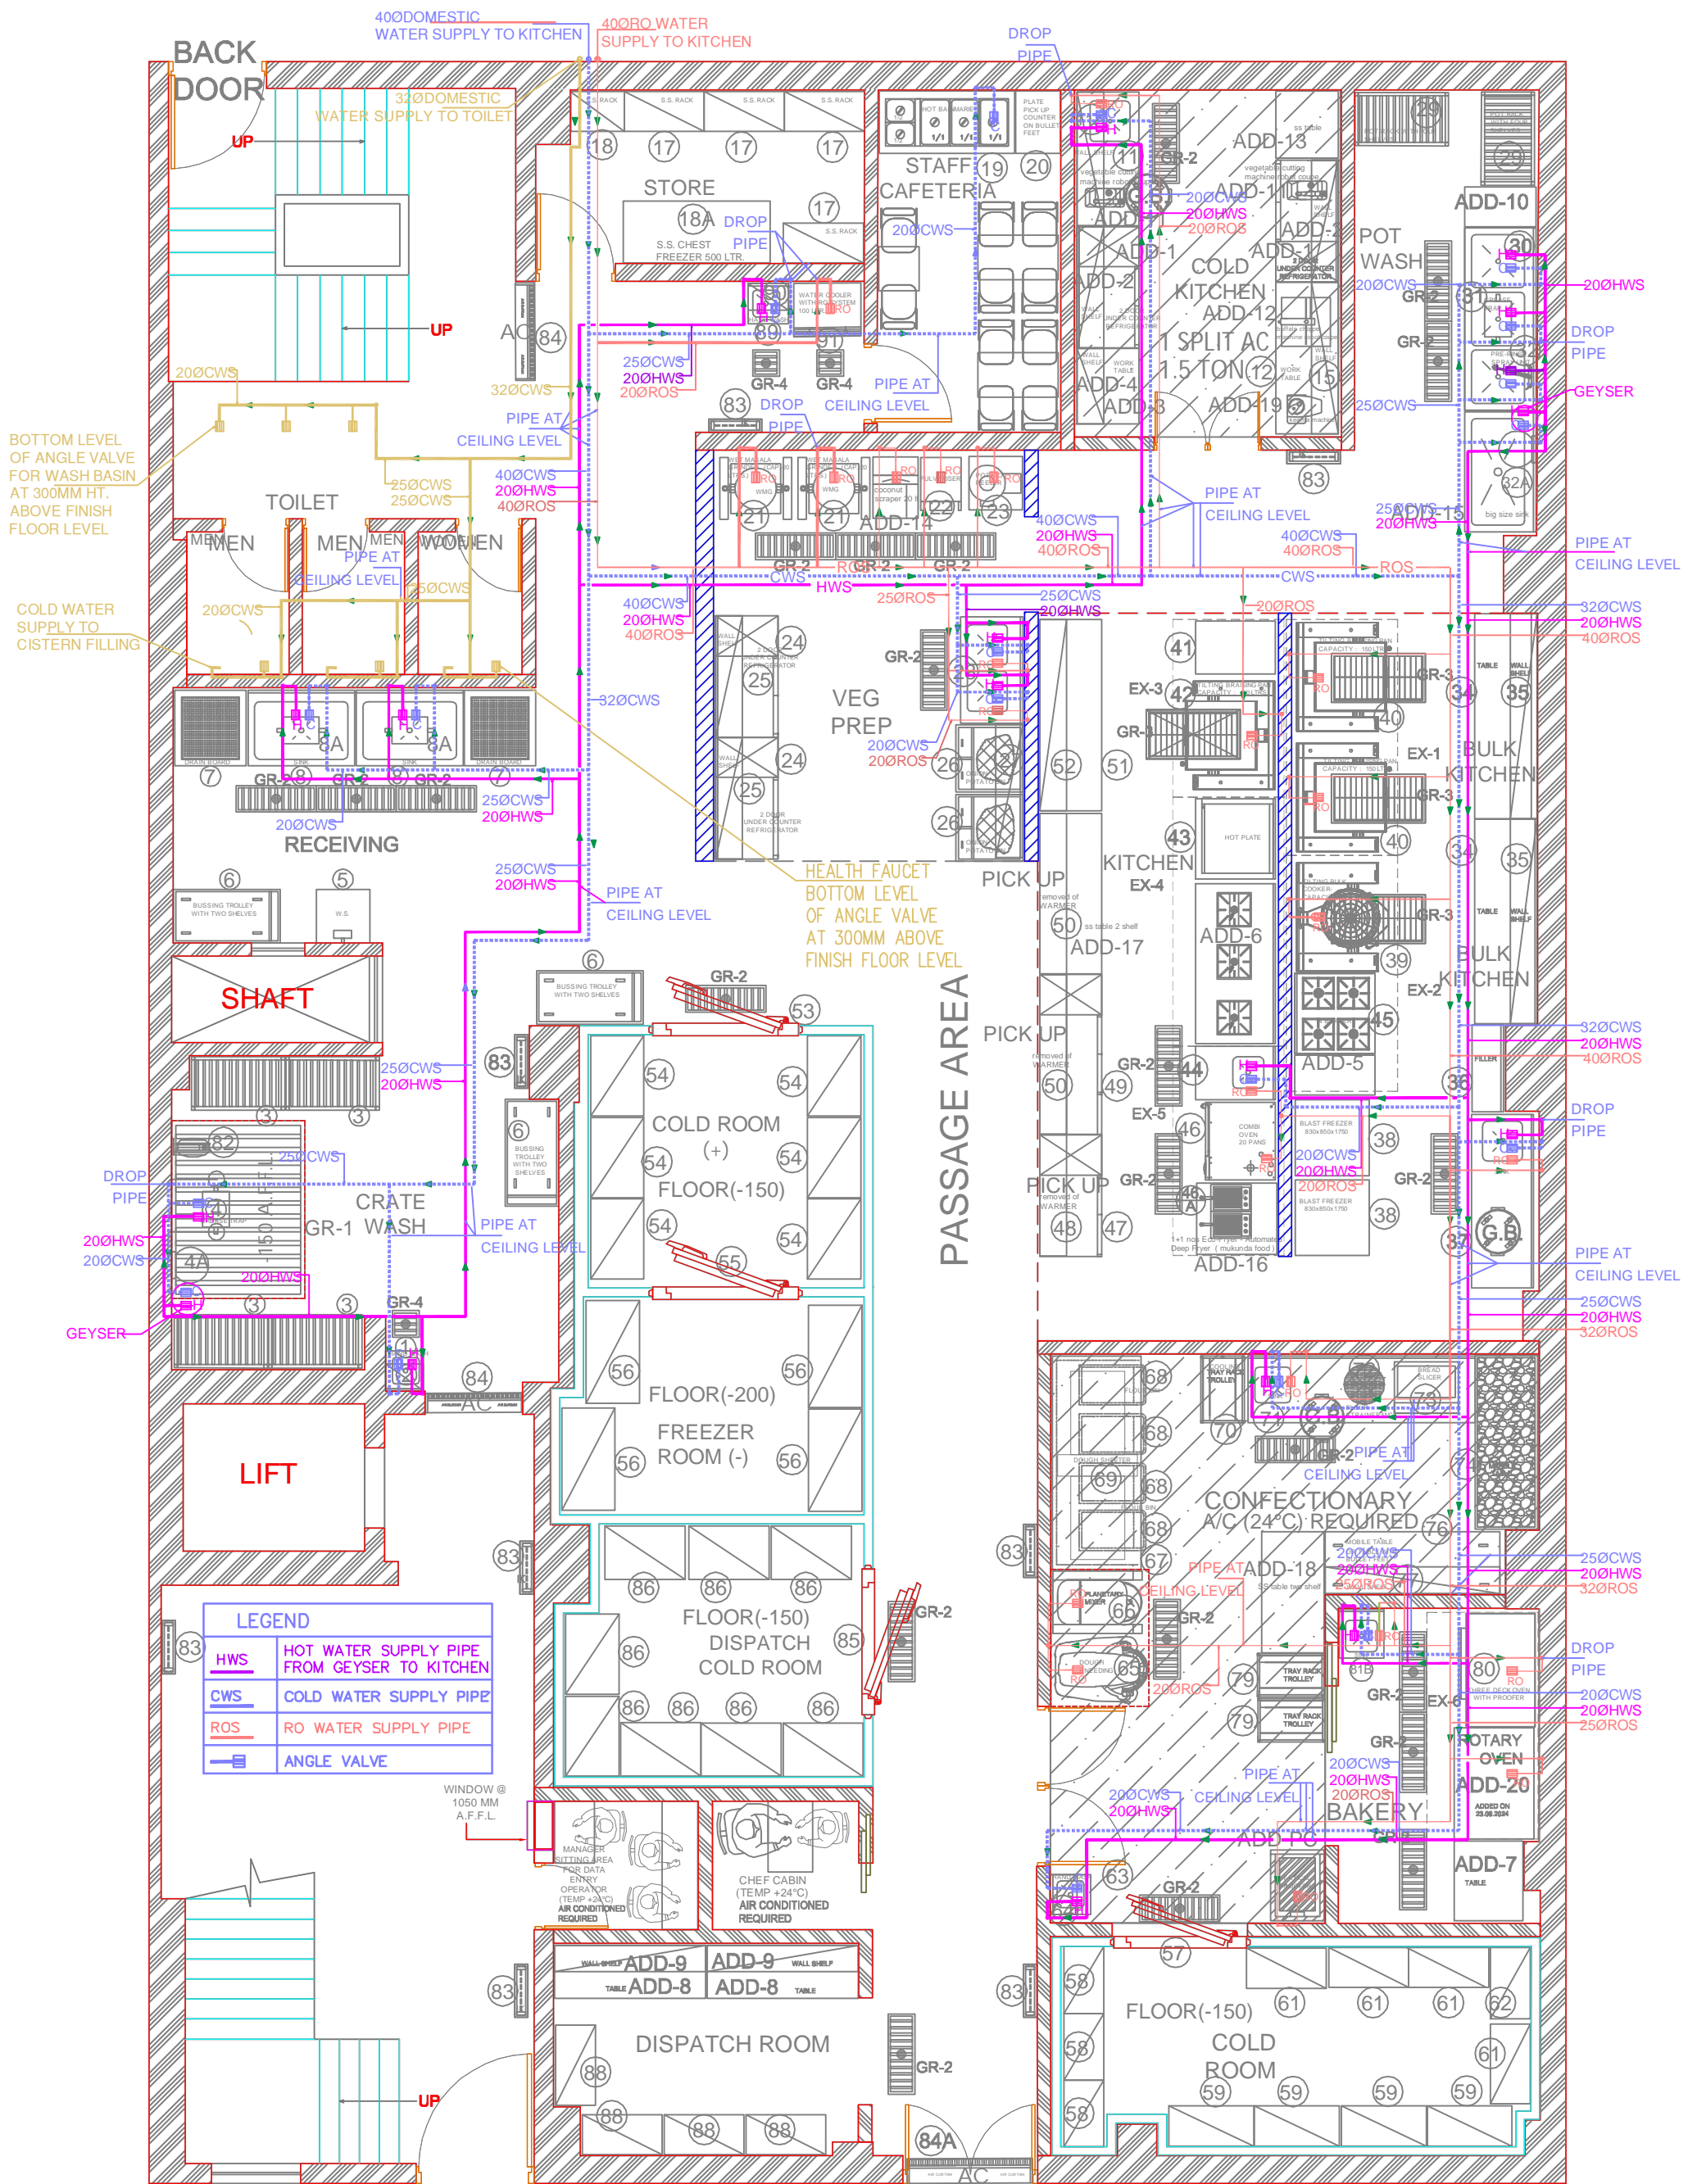

R.OFFICE: 186, BLOCK C-2C, POCKET 12, JANAK PURI, NEW DELHI, 110058
 e mail: design@classconsultants.in Office: +919212501725

THESE DRAWING AND SPECIFICATIONS ARE THE PROPERTY OF CLASS HOSPITALITY CONSULTANTS AND SHALL NOT BE COPIED OR REPRODUCED WITHOUT THEIR WRITTEN PERMISSION.

PROJECT TITLE
TFS BASE KITCHEN
MATIYALA DWARKA

DRAWING TITLE:
WATER SUPPLY LINE LAYOUT PLAN

20/07/2024/LAYOUT/REV000

DESIGN:

PREPARED BY:
VIBHA

SCALE: NTS

CAD FILE:F:/PROJECT

REV NO.

000

000

000

000

REVISION DATE


00/00/2024

00/00/2024

00/00/2024

00/00/2024

PROJECT DATE: 19/07/2024

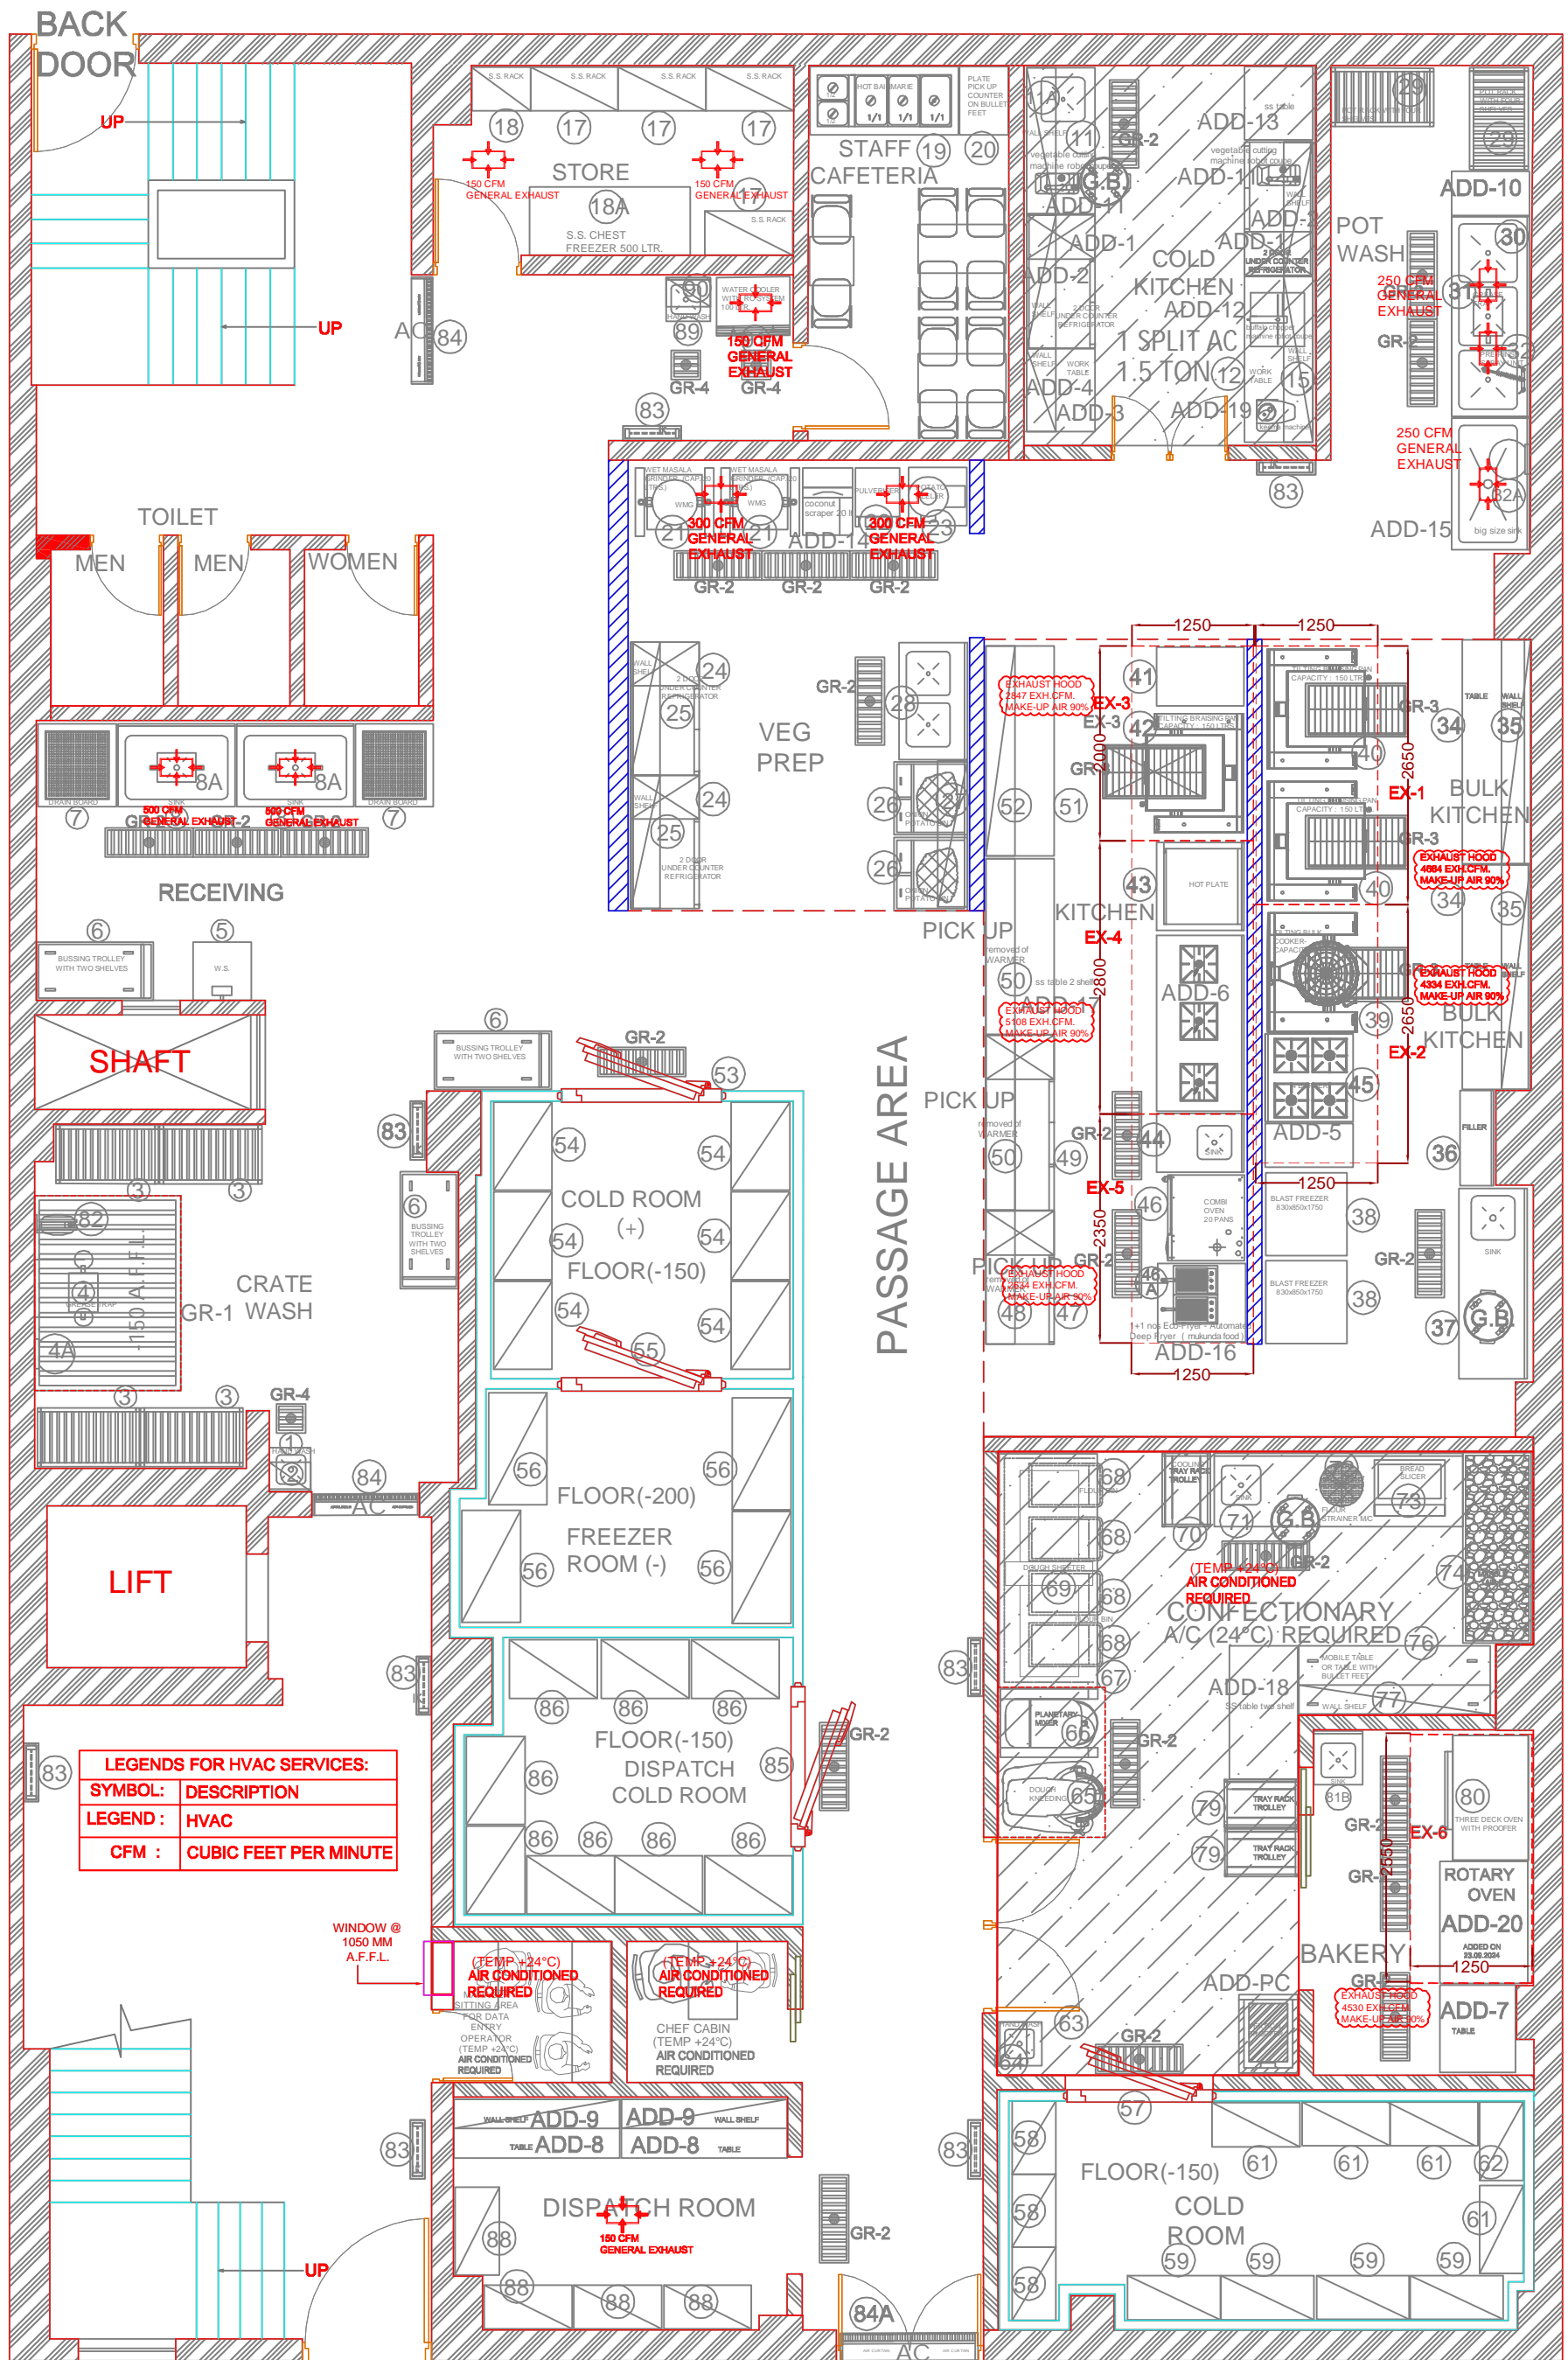

R.OFFICE: 186, BLOCK C-2C, POCKET 12, JANAK PURI, NEW DELHI, 110058
 e mail: design@classconsultants.in Office:-919212501725

THESE DRAWING AND SPECIFICATIONS ARE THE PROPERTY OF CLASS HOSPITALITY CONSULTANTS AND SHALL NOT BE COPIED OR REPRODUCED WITHOUT THEIR WRITTEN PERMISSION.

PROJECT TITLE
TFS BASE KITCHEN
MATIYALA DWARKA

DRAWING TITLE:
HVAC LAYOUT PLAN

20/07/2024/LAYOUT/REV000

DESIGN:

PREPARED BY:
VIBHA

SCALE: NTS

CAD FILE:F:/PROJECT

REV NO.

000

000

000

000

REVISION DATE


00/00/2024

00/00/2024

00/00/2024


00/00/2024

PROJECT DATE: 19/07/2024

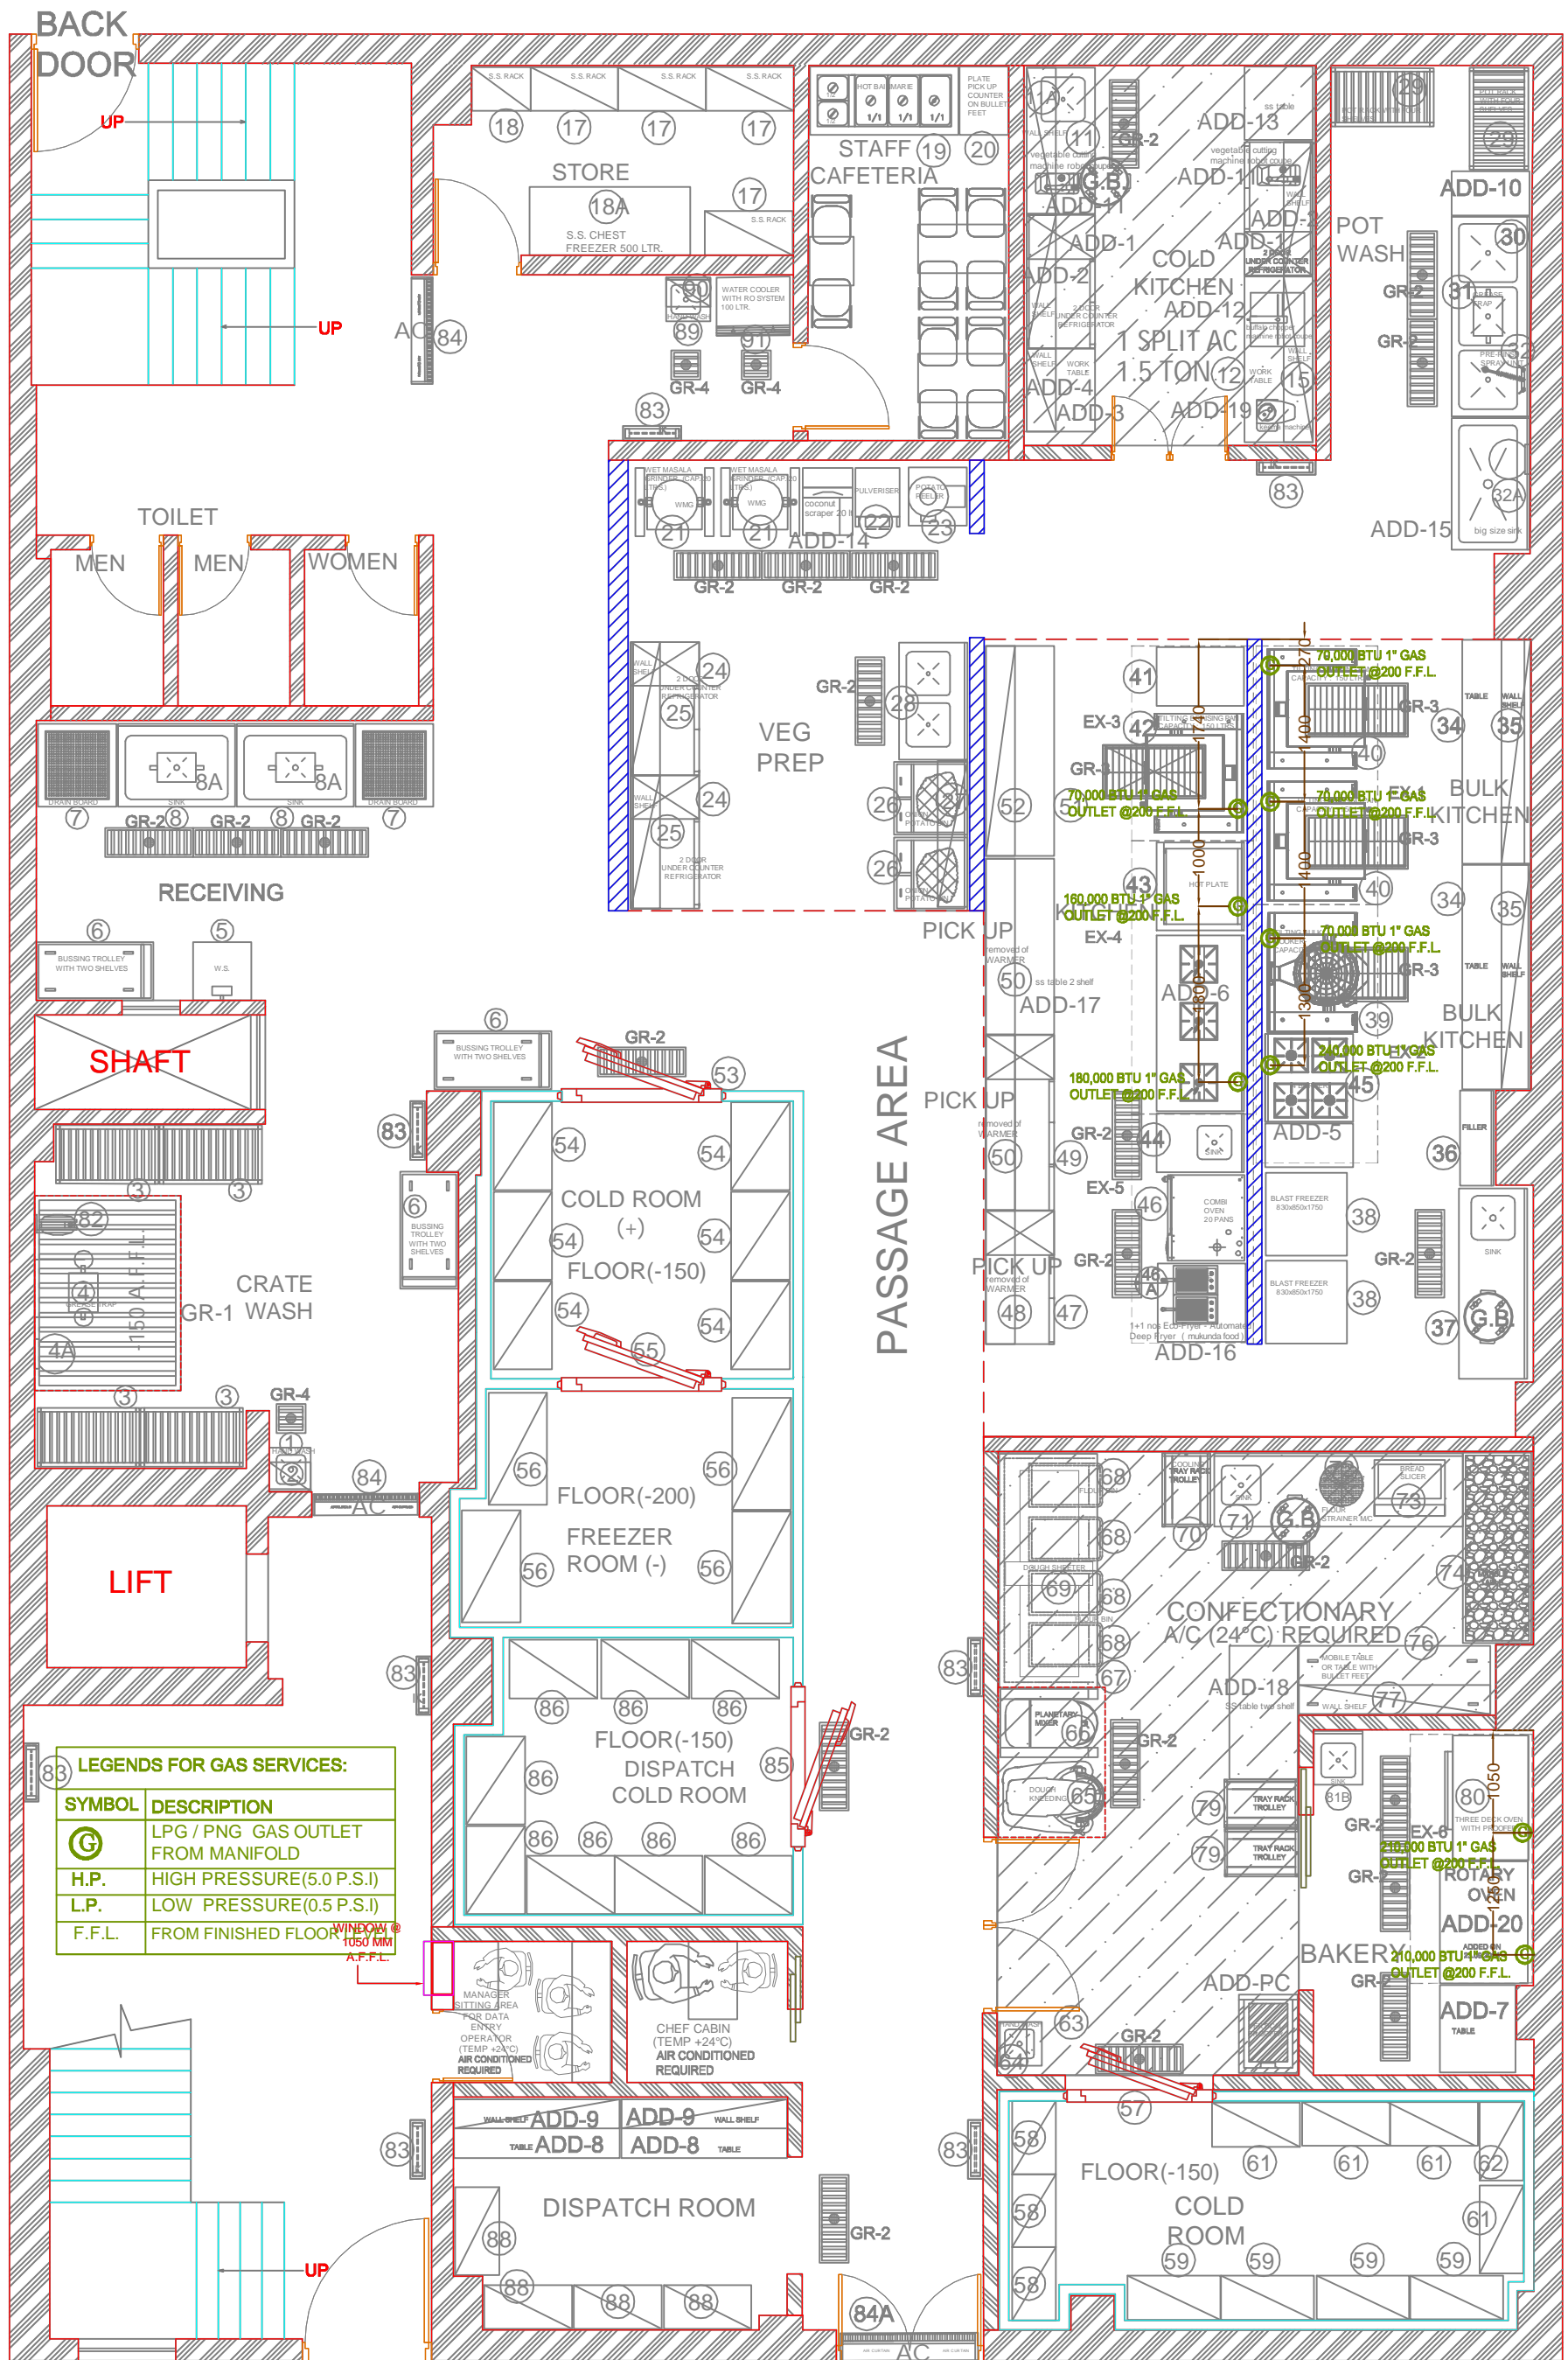

LEGENDS FOR GAS SERVICES:

SYMBOL	DESCRIPTION
G	LPG / PNG GAS OUTLET FROM MANIFOLD
H.P.	HIGH PRESSURE (5.0 P.S.I)
L.P.	LOW PRESSURE (0.5 P.S.I)
F.F.L.	FROM FINISHED FLOOR LEVEL

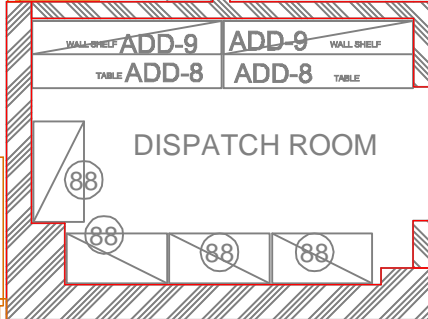

R.OFFICE: 186, BLOCK C-2C, POCKET 12, JANAK PURI, NEW DELHI, 110058
 e mail: design@classconsultants.in Office: +919212501725

THESE DRAWING AND SPECIFICATIONS ARE THE PROPERTY OF CLASS HOSPITALITY CONSULTANTS AND SHALL NOT BE COPIED OR REPRODUCED WITHOUT THEIR WRITTEN PERMISSION.

PROJECT TITLE
TFS BASE KITCHEN
MATIYALA DWARKA

DRAWING TITLE:
GAS LAYOUT PLAN


20/07/2024/LAYOUT/REV000

DESIGN:
PREPARED BY:
SCALE: NTS

REV NO.	REVISION DATE
000	00/00/2024
000	00/00/2024
000	00/00/2024
000	00/00/2024

CAD FILE:F:/PROJECT

PROJECT DATE: 19/07/2024

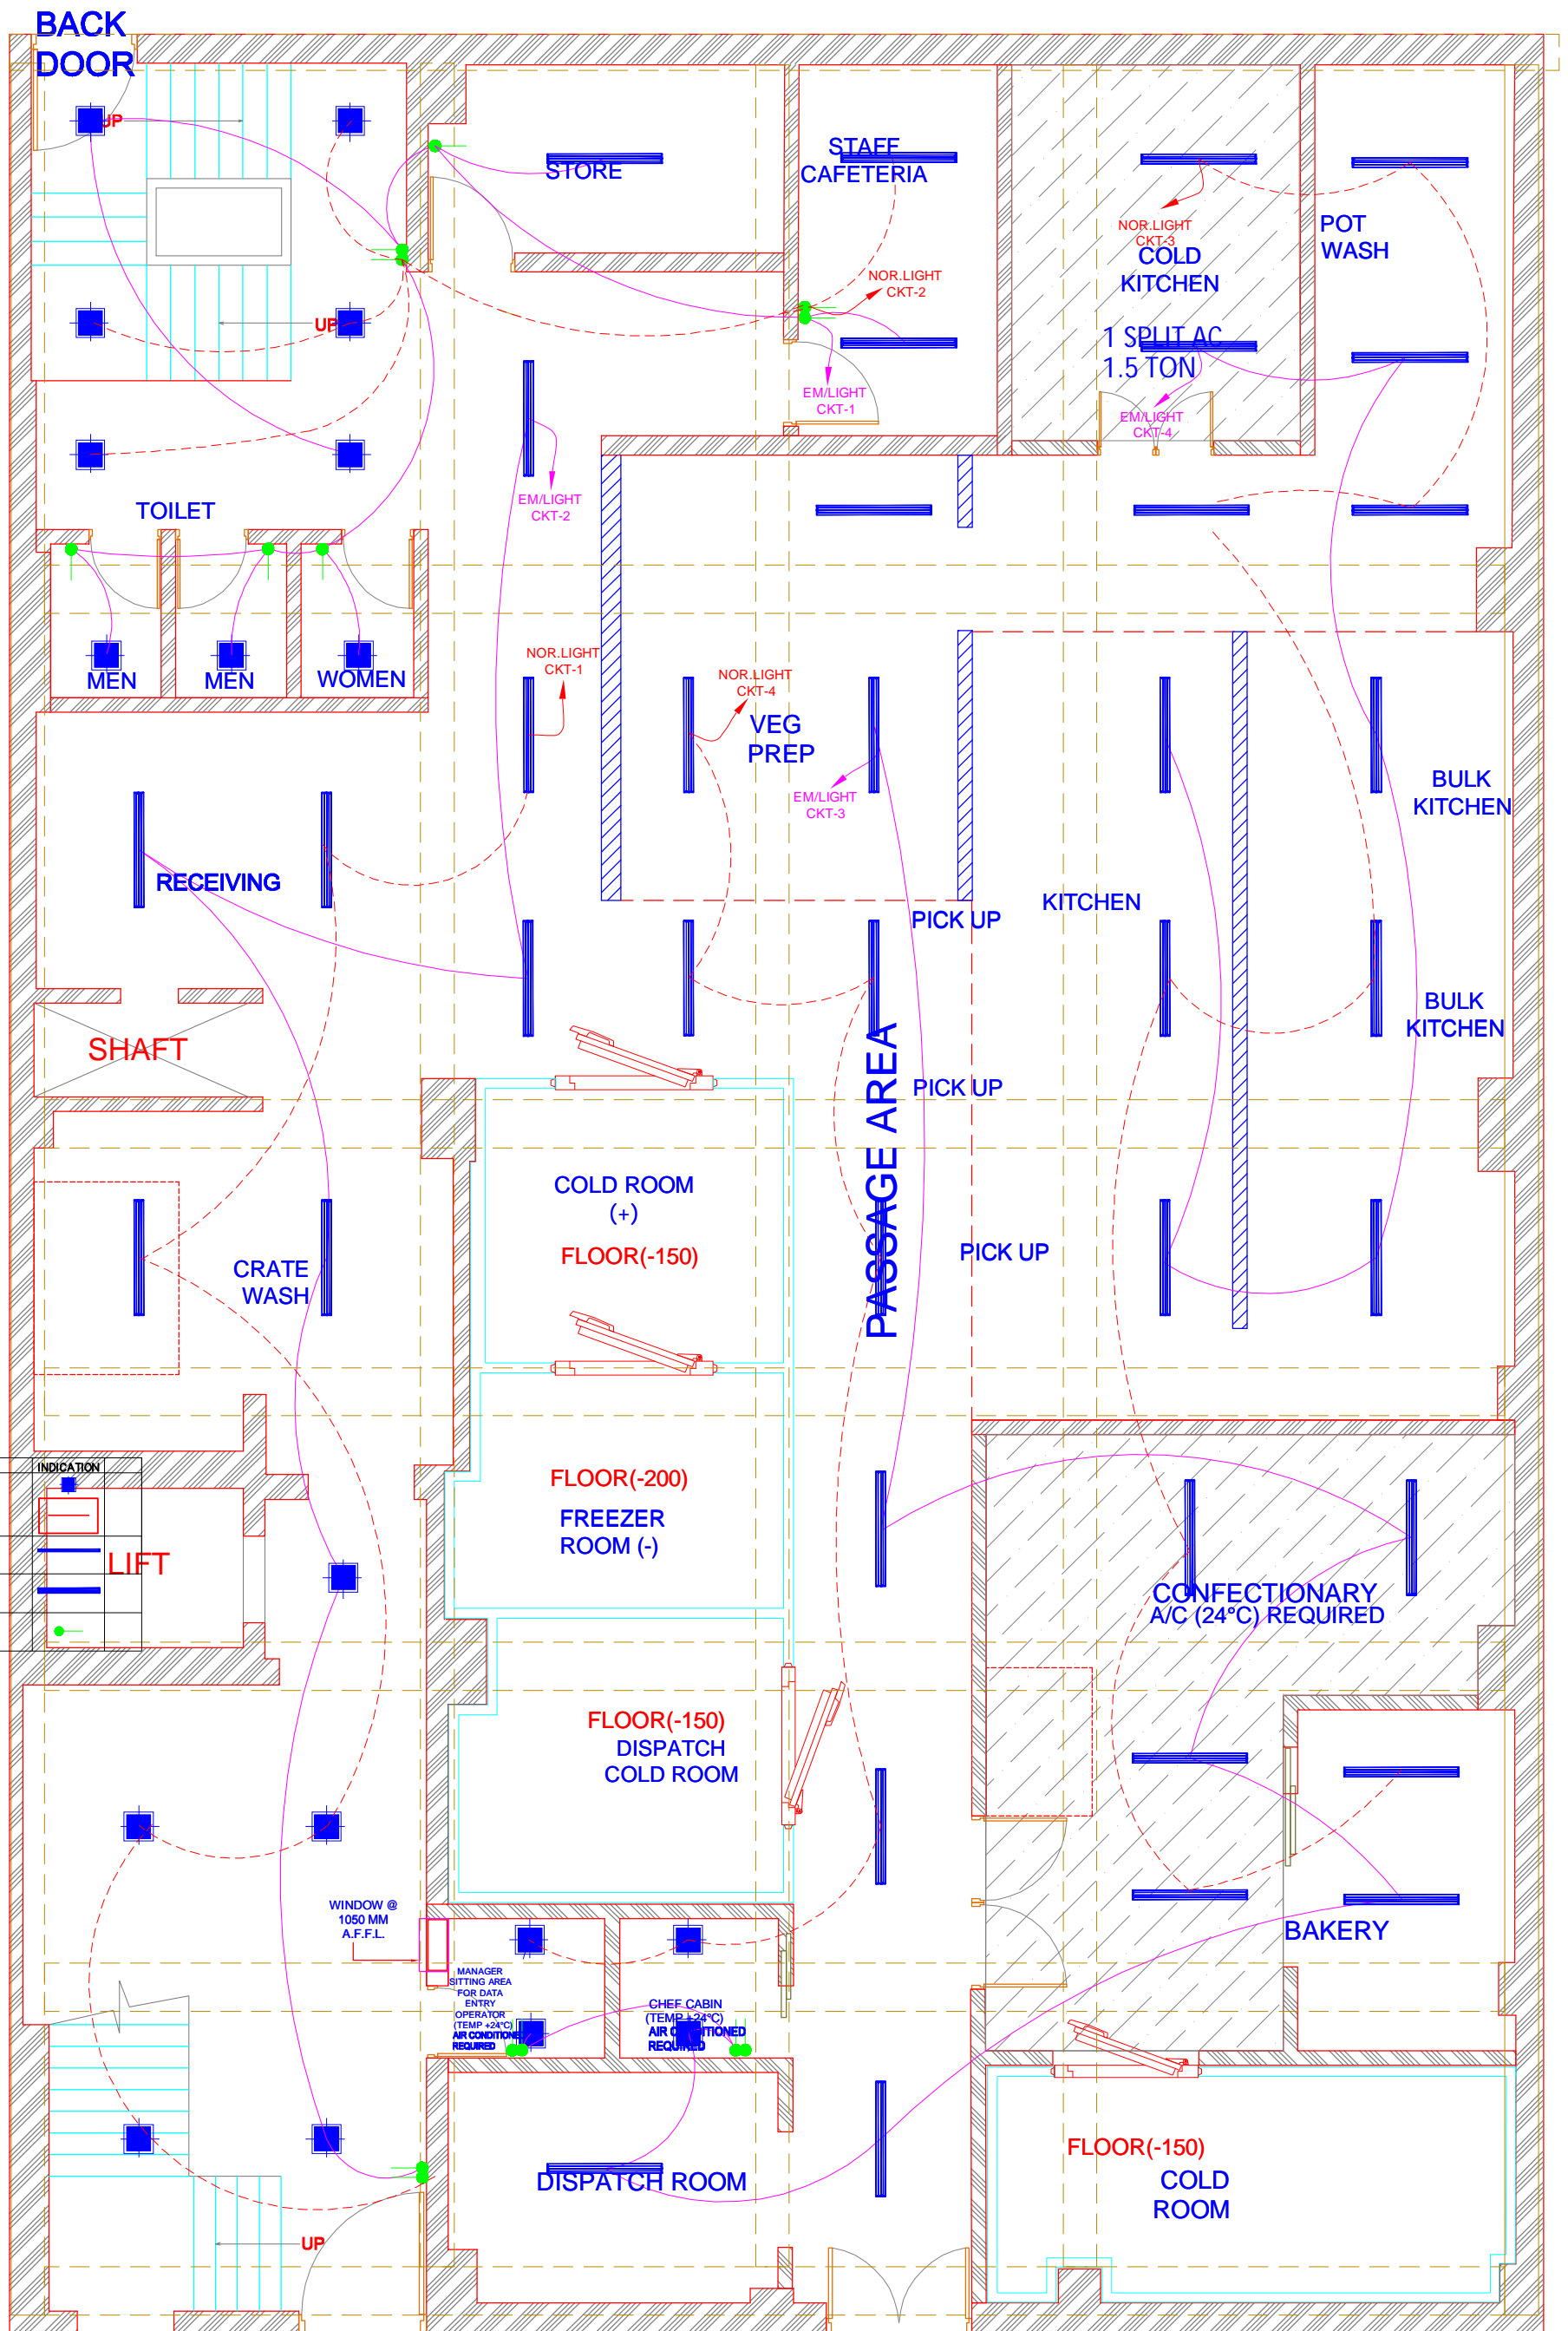


LIGHTING LEGEND -

NO.	DESCRIPTION	INDICATION
01	LED LIGHTS (MCH AREA & EXTERIOR PASSAGE) SQUARE CEILING MOUNTED FITTING WITH 175MM X 175MM OFF WHITE POWDER COATED	
02	4'-0" L BATTEN TS LED LIGHT FIXTURE (SUSPENDED) NOTE:- HEIGHT OF LIGHT FIXTURE FROM FFL-2400MM	
03	4'-0" L BATTEN 2 NOS. TS LED LIGHT FIXTURE (SUSPENDED) NOTE:- HEIGHT OF LIGHT FIXTURE FROM FFL-2400MM	
04	SWITCH BOARD	

INDICATION

LIFT

LEGEND	
*	PENDENT SPRINKLER
—	SPRINKLER PIPE

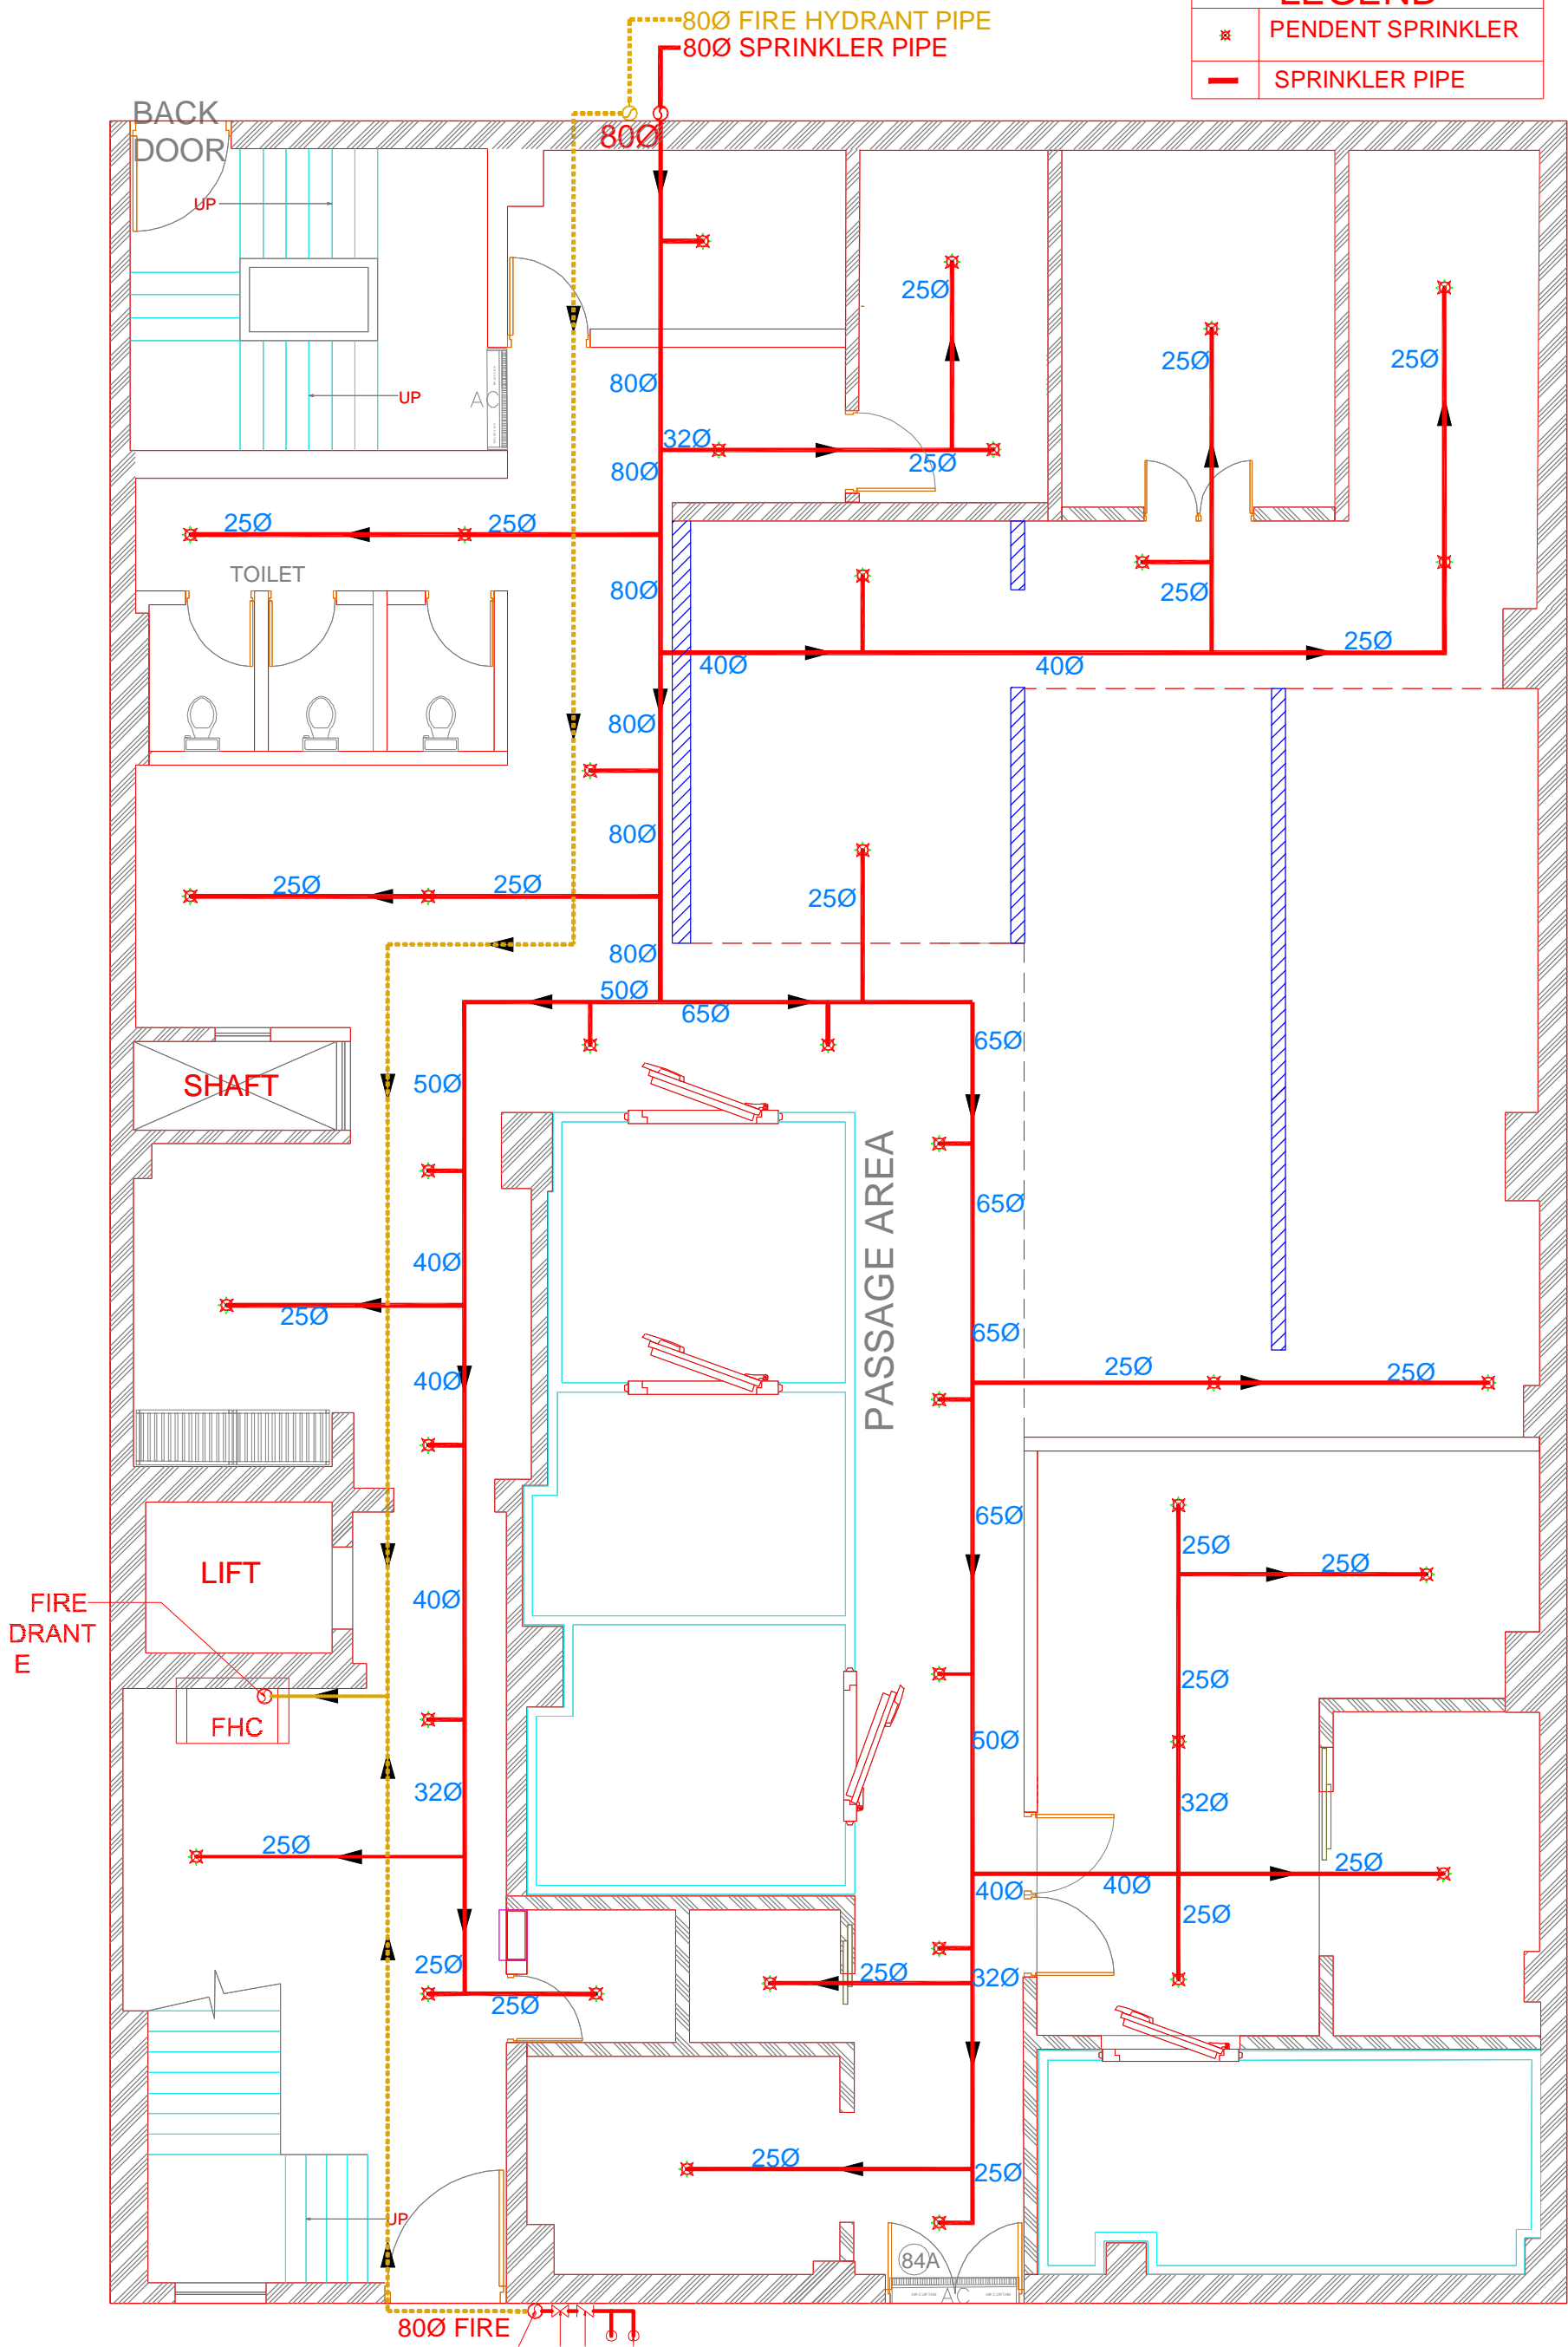

R.OFFICE: 186, BLOCK C-2C, POCKET 12, JANAK PURI, NEW DELHI, 110058
e mail: design@classconsultants.in Office:-919212501725

THESE DRAWING AND SPECIFICATIONS ARE THE PROPERTY OF CLASS HOSPITALITY CONSULTANTS AND SHALL NOT BE COPIED OR REPRODUCED WITHOUT THEIR WRITTEN PERMISSION.

PROJECT TITLE
**TFS BASE KITCHEN
MATIYALA DWARKA**

DRAWING TITLE:
FIRE FIGHTING

20/07/2024/LAYOUT/REV000

DESIGN:

PREPARED BY:
VIBHA

SCALE: NTS

CAD FILE:F:/PROJECT

REV NO.

001

002

003

004

REVISION DATE

12/08/2024


26/08/2024

05/09/2024

18/09/2024

PROJECT DATE: 19/07/2024

KITCHEN VENTILATION SYSTEM

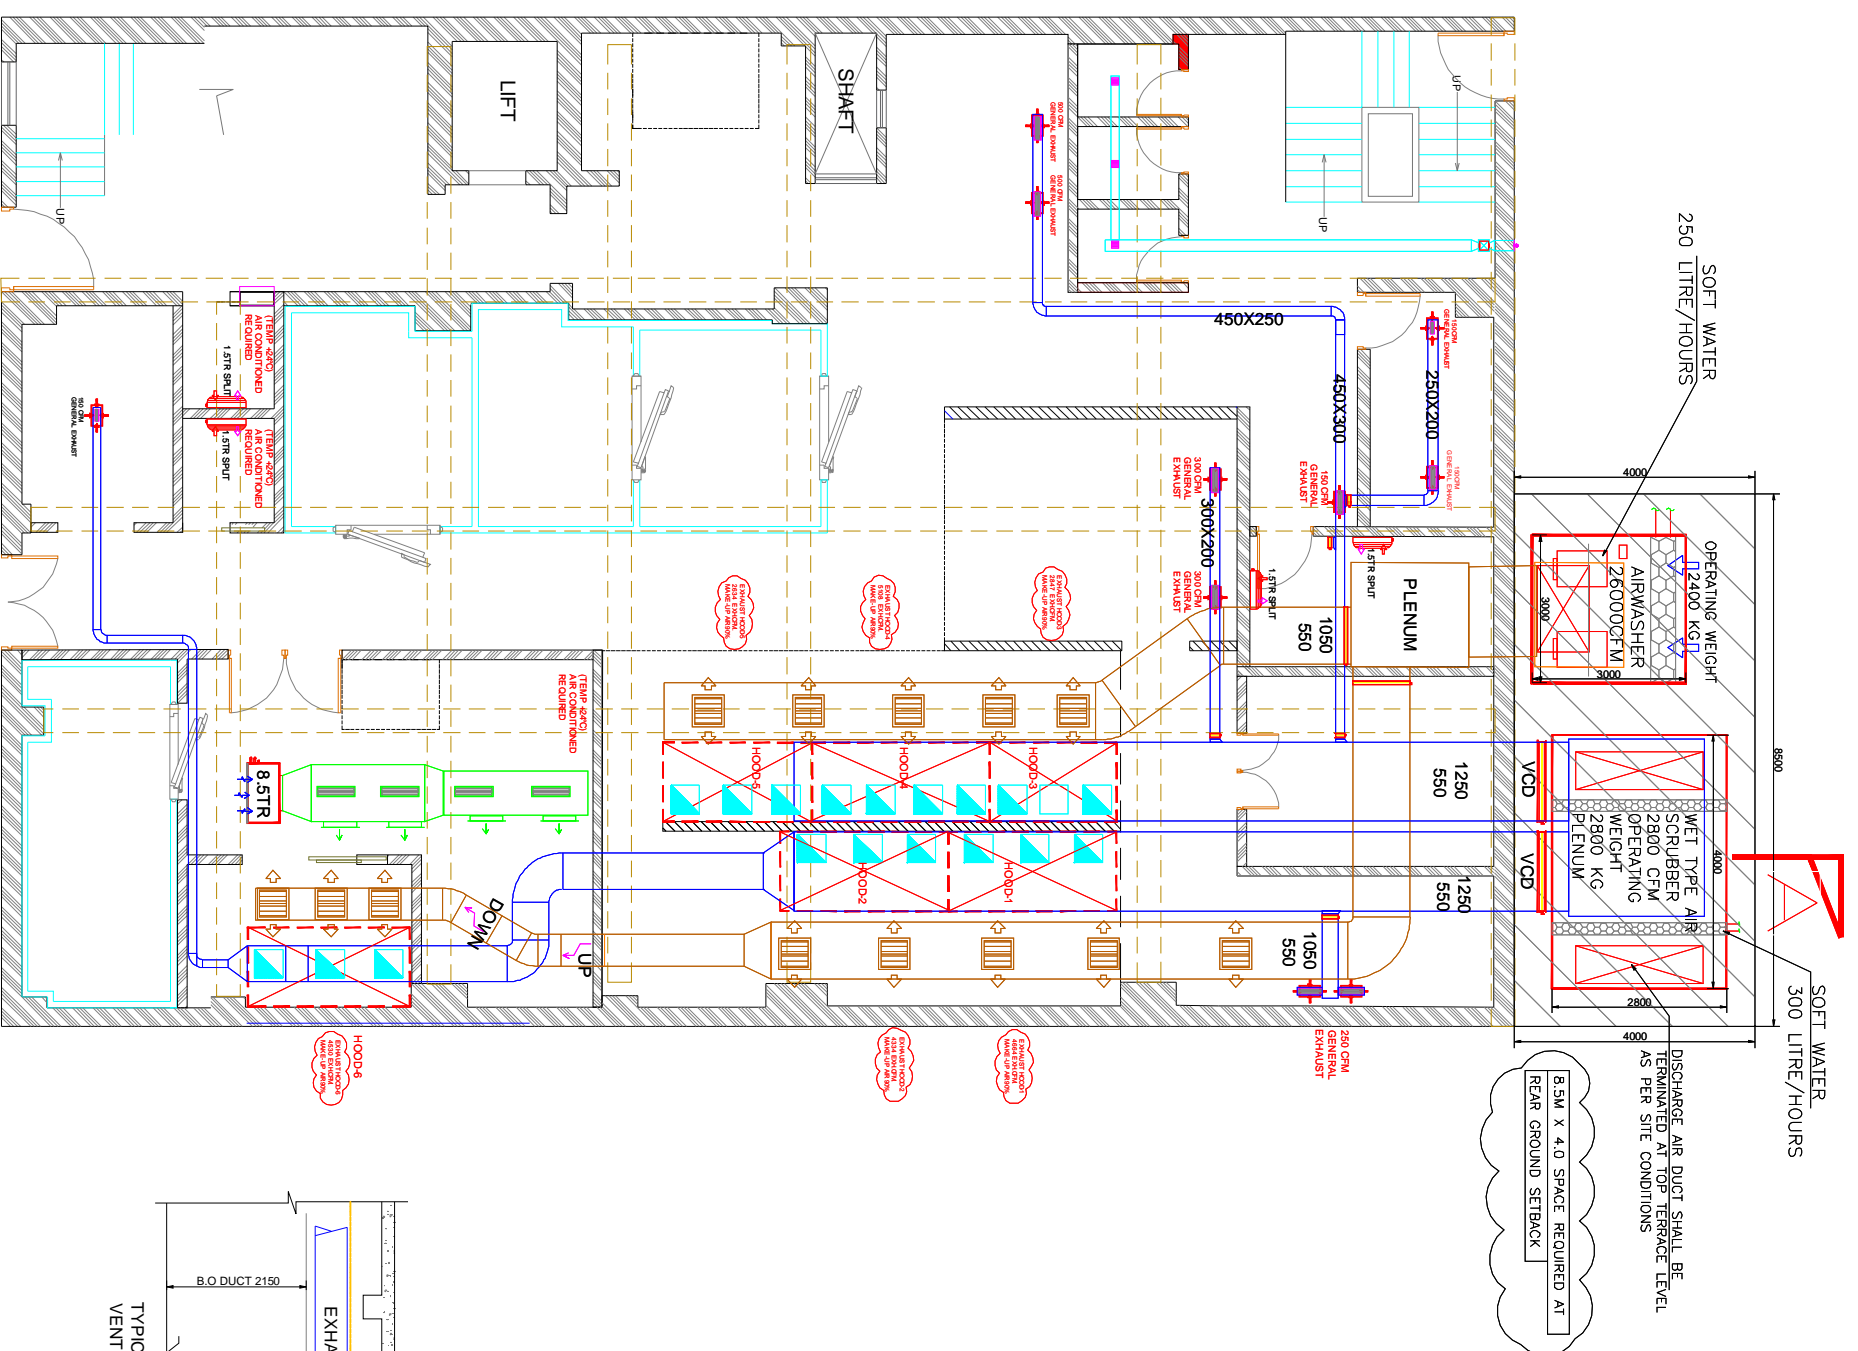

SOFT WATER
250 LITRE/HOURS

OPERATING WEIGHT
12400 KG/L

AIR WASHER
26000CFM

SOFT WATER
300 LITRE/HOURS

WET TYPE AIR SCRUBBER
2800 CFM
OPERATING WEIGHT
2800 KG


PLENUM


VCD

VCD

DISCHARGE AIR DUCT SHALL BE TERMINATED AT TOP TERRACE LEVEL AS PER SITE CONDITIONS

8.5M X 4.0 SPACE REQUIRED AT REAR GROUND SETBACK

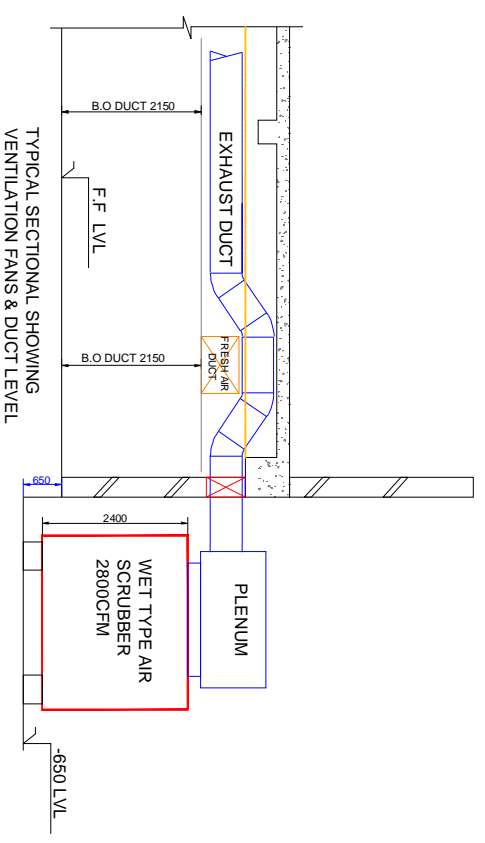



REPORT: 1A, BLOCK C.C. POCKET 3 LANKA POKET NEW DUDA, HIRAK
e-mail: design@ccpocket.lanka.com, in: Office+91212501725
THESE DRAWINGS AND SPECIFICATIONS ARE THE PROPERTY OF C.C. POCKET LANKA POKET
CONSTRUCTION AND SHALL NOT BE COPIED OR REPRODUCED WITHOUT THE WRITTEN
PERMISSION

PROJECT TITLE


TFS BASE KITCHEN

MATTYALA DWARKA

DRAWING TITLE:

KITCHEN VENTILATION SYSTEM

DESIGN:	REVISION DATE:
DESIGNED BY: VASILA	01
CHECKED BY: VASILA	02
SCALE: NYS	03
CAD FILE: /PROJECT	04
PROJECT DATE: 18/07/2024	

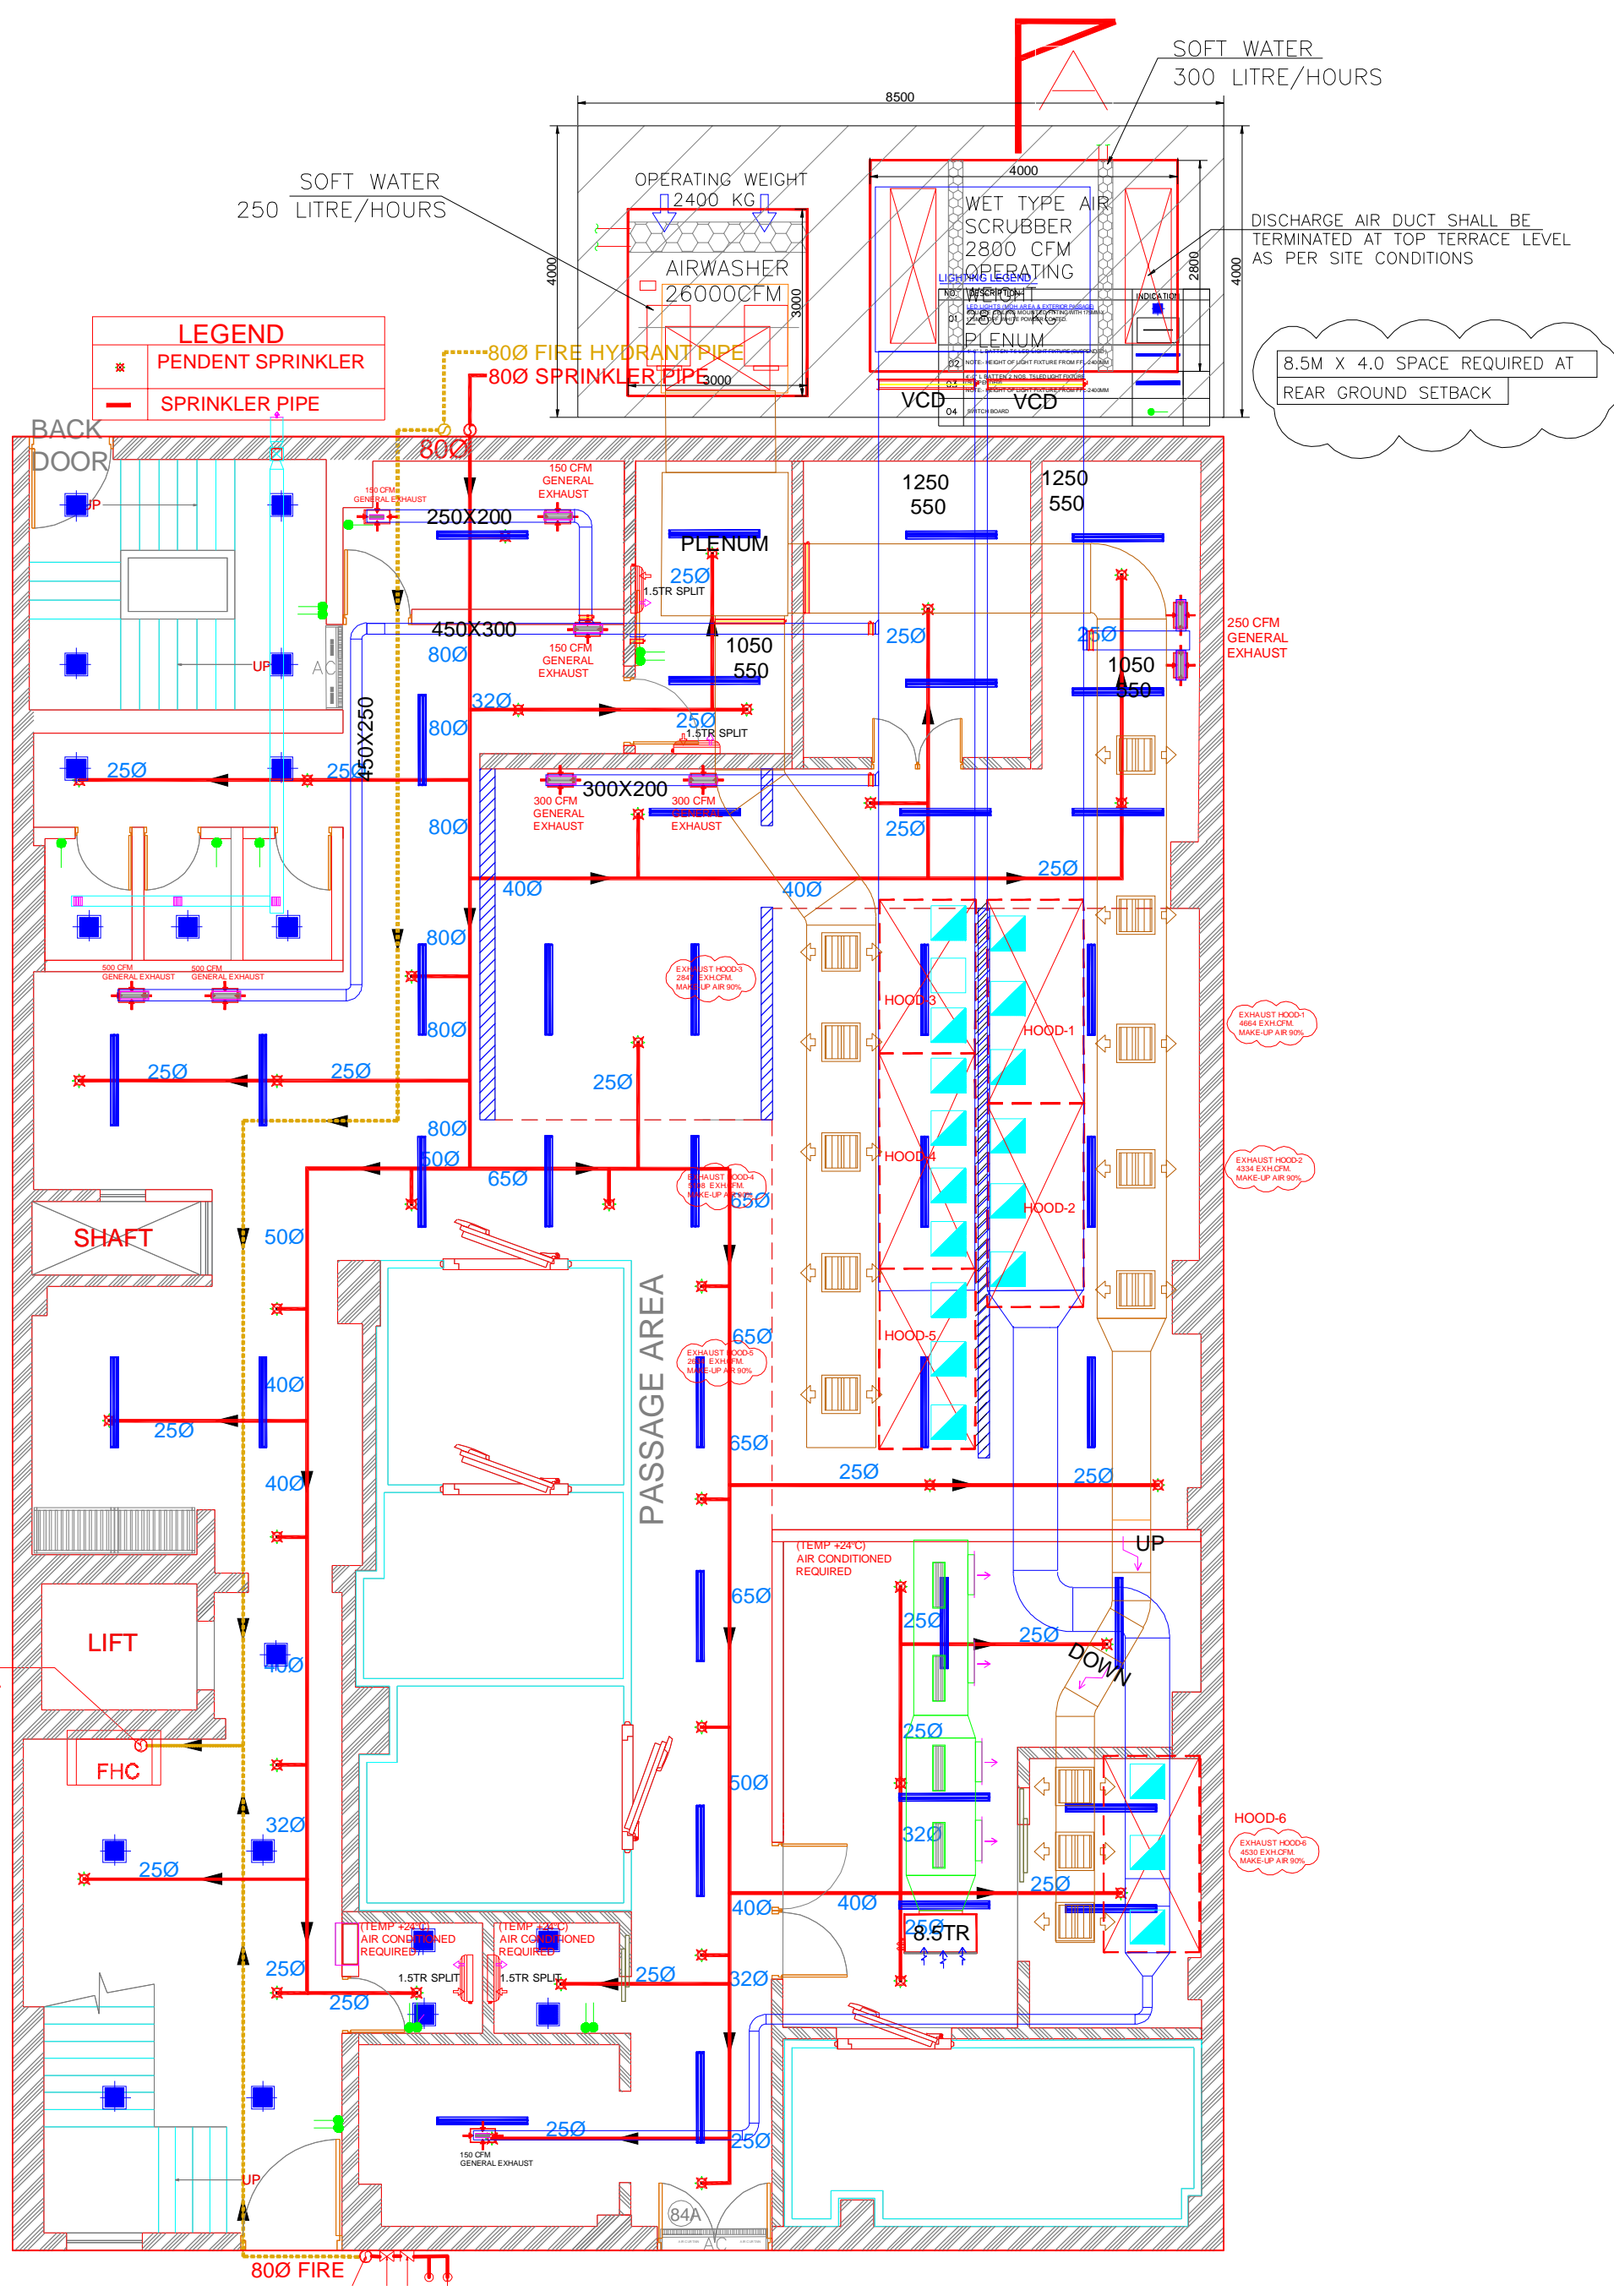


LEGEND	
* (with asterisk symbol)	PENDENT SPRINKLER
— (with red line)	SPRINKLER PIPE


8.5M X 4.0 SPACE REQUIRED AT REAR GROUND SETBACK

REV NO.	REVISION DATE
001	12/08/2024
002	26/08/2024
003	05/09/2024
004	18/09/2024

 PROJECT DATE: 19/07/2024



Prepolished 20 mm Kota with Myk laticrete epoxy grout

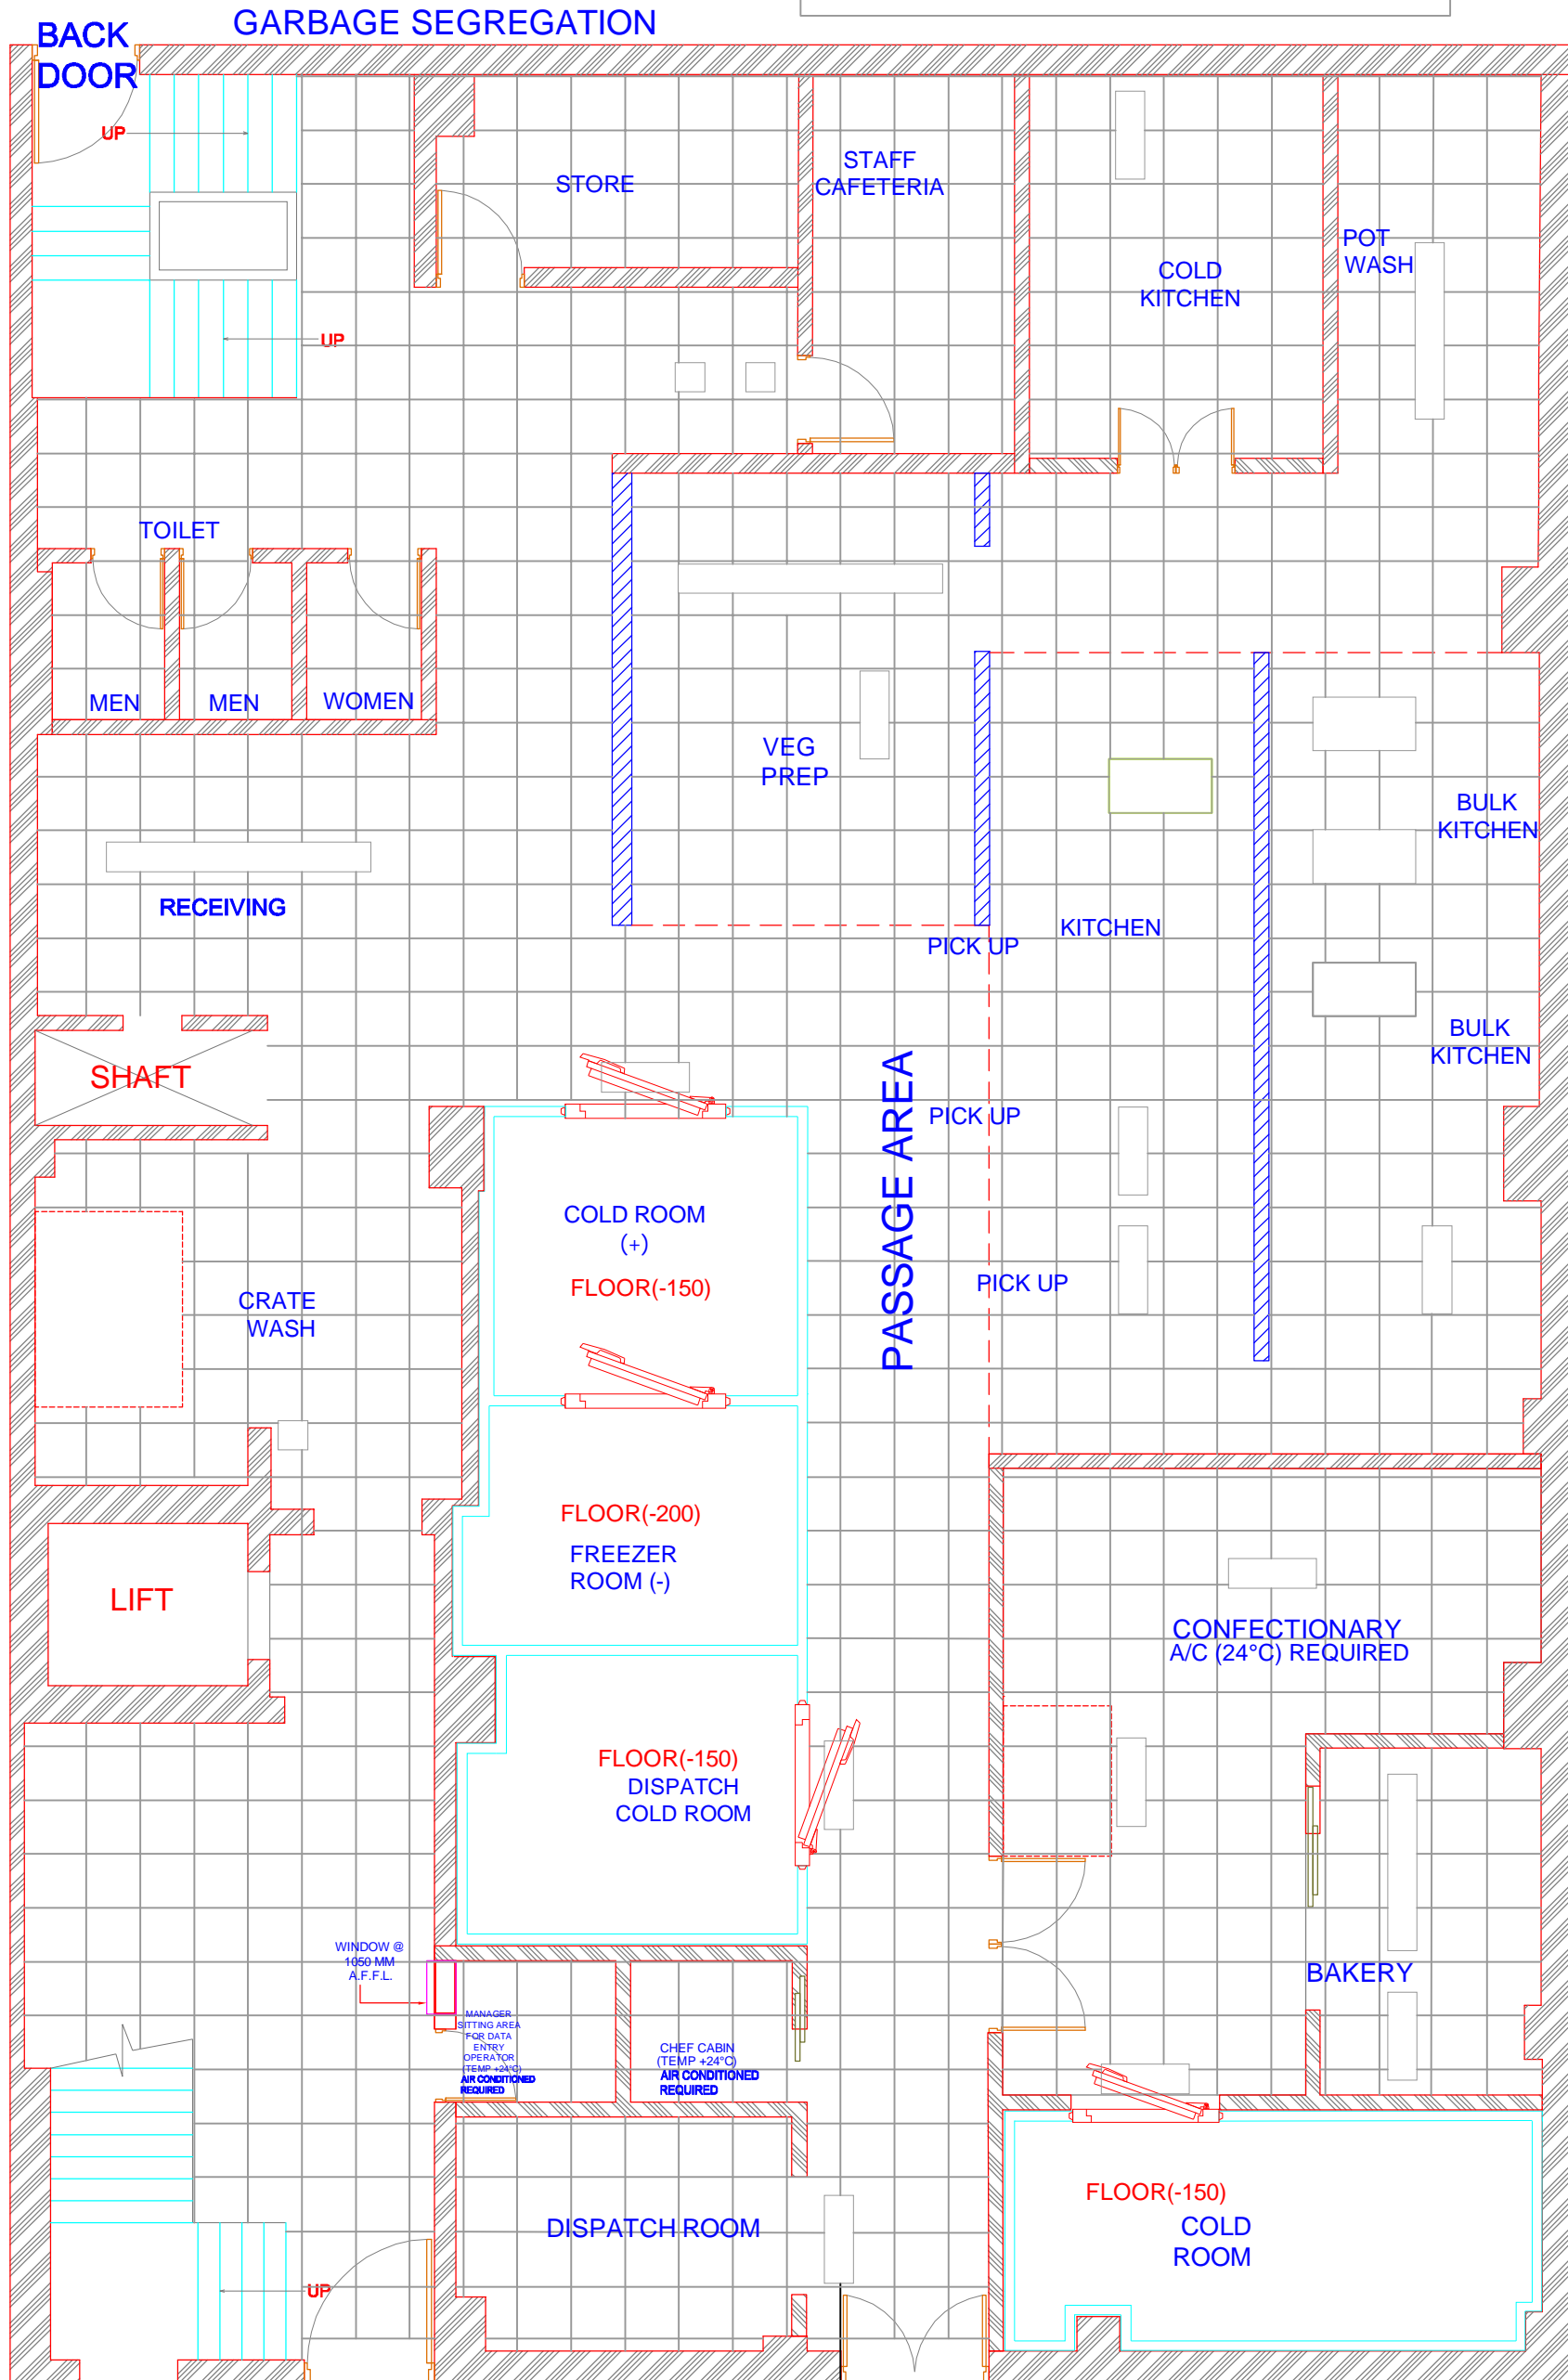

R.OFFICE: 186, BLOCK C-2C, POCKET 12, JANAK PURI, NEW DELHI, 110058
e mail: design@classconsultants.in Office:-919212501725

THESE DRAWING AND SPECIFICATIONS ARE THE PROPERTY OF CLASS HOSPITALITY CONSULTANTS AND SHALL NOT BE COPIED OR REPRODUCED WITHOUT THEIR WRITTEN PERMISSION.

PROJECT TITLE
**TFS BASE KITCHEN
MATIYALA DWARKA**

DRAWING TITLE:
FLOOR TILE PLAN

20/07/2024/LAYOUT/REV000

DESIGN:

PREPARED BY:
VIBHA

SCALE: NTS

CAD FILE:F:/PROJECT

REV NO.

001

002

003

004

REVISION DATE



12/08/2024


26/08/2024

05/09/2024

18/09/2024

PROJECT DATE: 19/07/2024

	Ivory white emulsion paint
	Ceramic white 450 X 300 without groove with white Myk Latiretre Epoxy grout

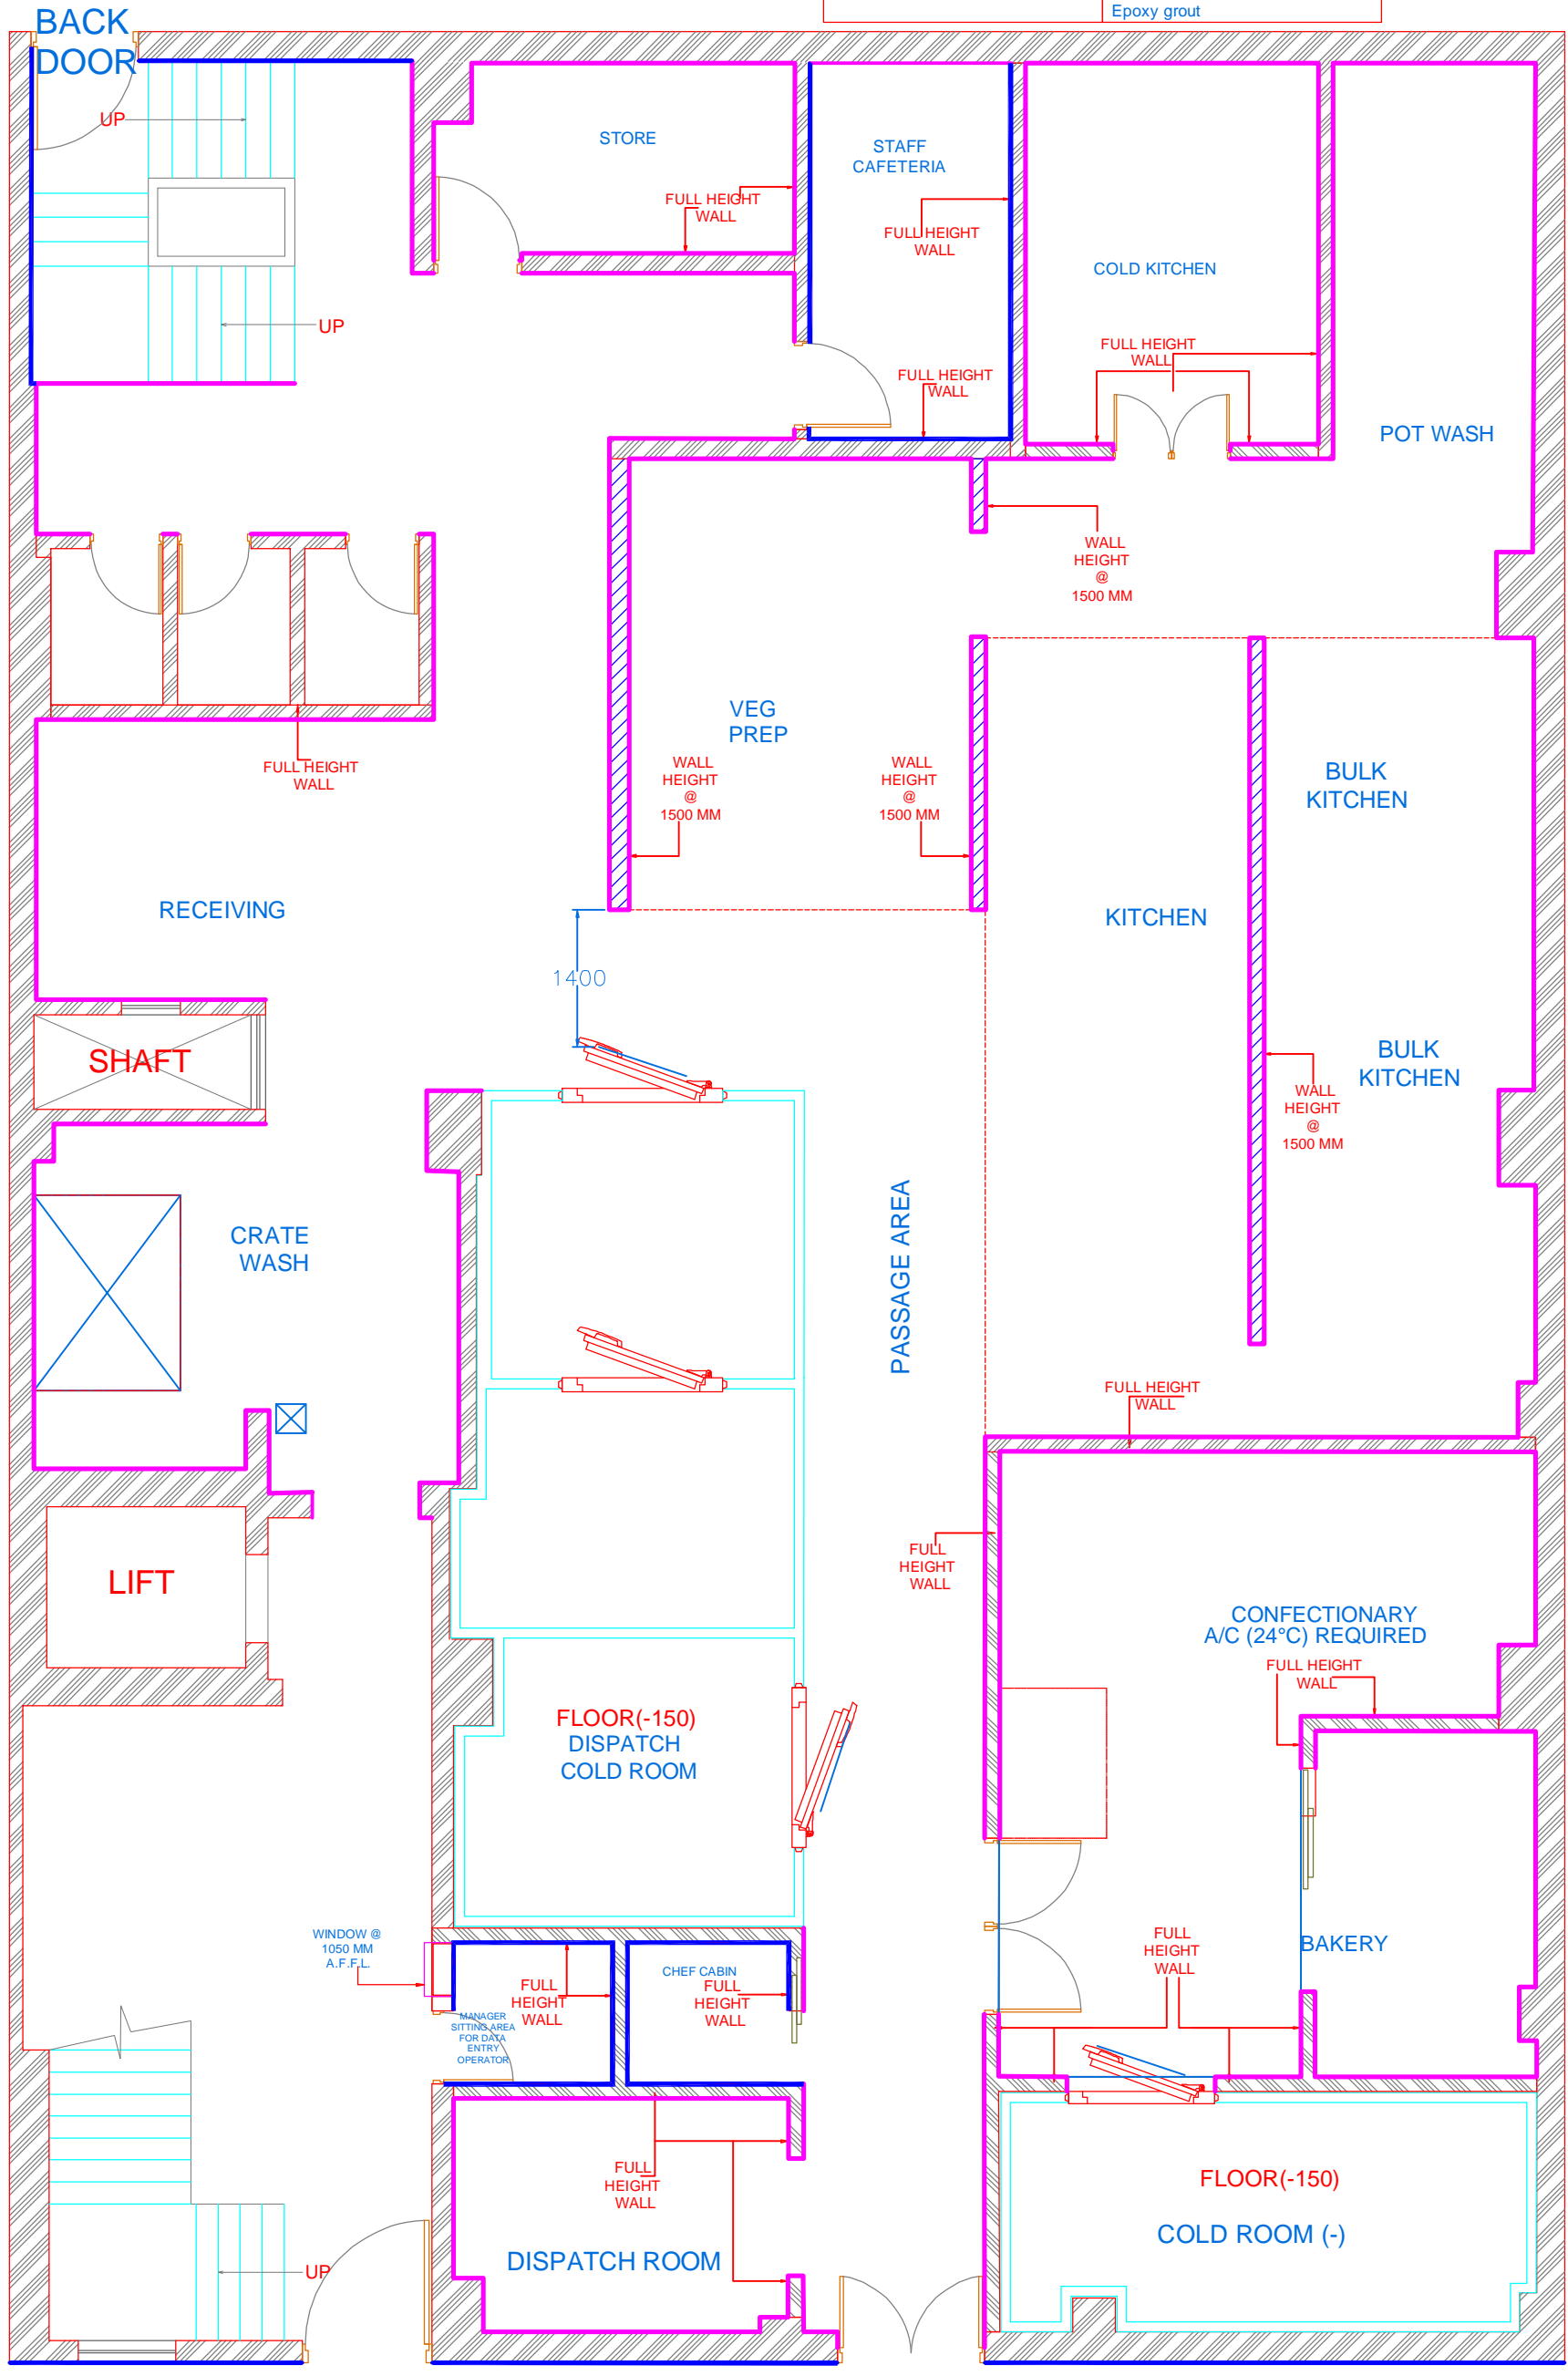

R.OFFICE: 186, BLOCK C-2C, POCKET 12, JANAK PURI, NEW DELHI, 110058
 e mail: design@classconsultants.in Office:-919212501725

THESE DRAWING AND SPECIFICATIONS ARE THE PROPERTY OF CLASS HOSPITALITY CONSULTANTS AND SHALL NOT BE COPIED OR REPRODUCED WITHOUT THEIR WRITTEN PERMISSION.

PROJECT TITLE
TFS BASE KITCHEN
MATIYALA DWARKA

DRAWING TITLE:
WALLING TILE PLAN

20/07/2024/LAYOUT/REV000

DESIGN:

PREPARED BY:
 VIBHA

SCALE: NTS

CAD FILE:F:/PROJECT

REV NO.

001

002

003

004

REVISION DATE

12/08/2024




26/08/2024

 
05/09/2024

18/09/2024

PROJECT DATE: 19/07/2024

CABIN SECTION

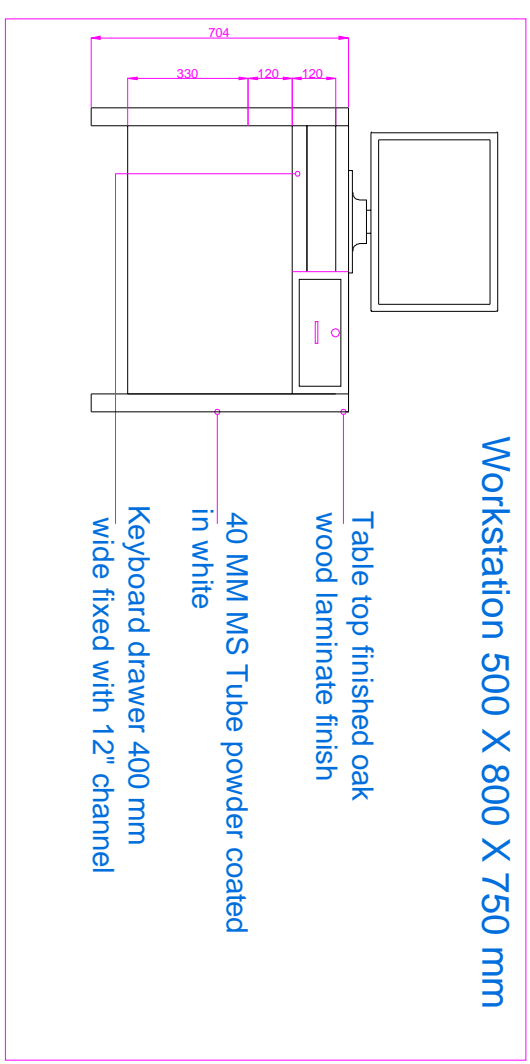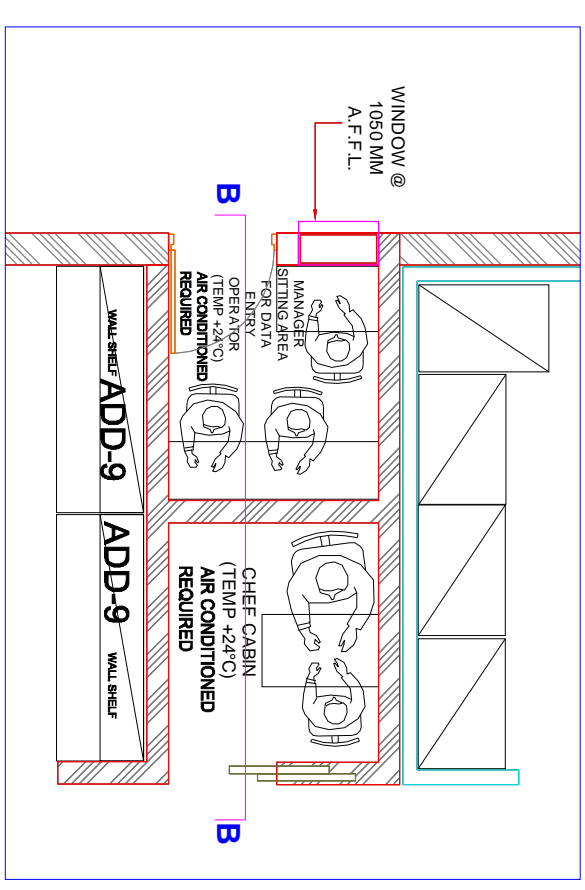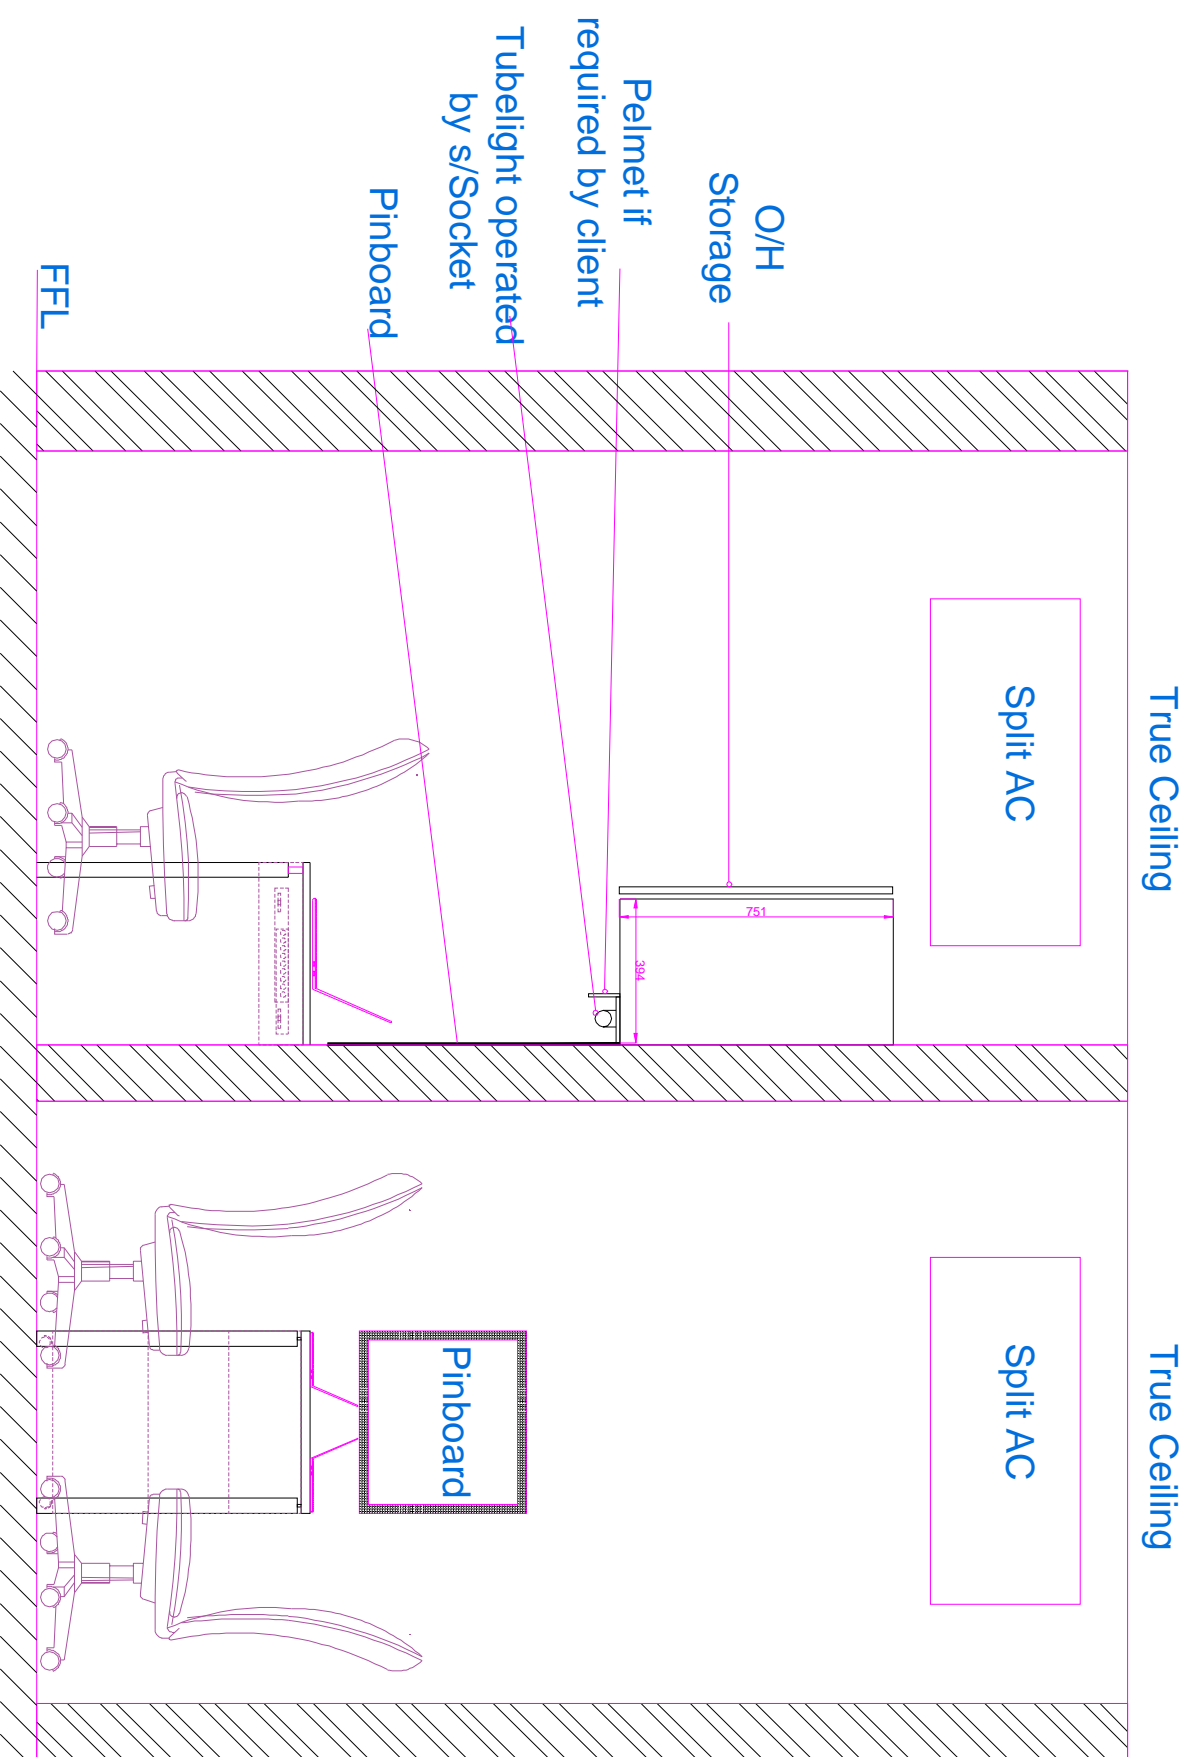

		PROJECT TITLE TFS BASE KITCHEN MATTYALA DWARKA	
DRAWING TITLE: CABIN SECTION		DESIGN:	
KEY NO.		REVISION DATE	
PREPARED BY: VISHA		001 12/09/2024	
SCALE: NYS		002 28/09/2024	
CAD FILE#: /PROJECT		003 04/09/2024	
PROJECT DATE: 18/07/2024		004 18/09/2024	

REPORT: 1A, BLOCK: C-2, PLOT: 1, JANAKI, RAJAN, NEW DELHI, 11008
 e-mail: design@gpengineers.com, in: Office+919212501725
 THESE DRAWINGS AND SPECIFICATIONS ARE THE PROPERTY OF G.P. ENGINEERS, ARCHITECTS AND DESIGNERS. ANY REPRODUCTION OR TRANSMISSION OF THESE DRAWINGS WITHOUT THE WRITTEN PERMISSION OF G.P. ENGINEERS, ARCHITECTS AND DESIGNERS IS STRICTLY PROHIBITED.

